

# INTERIOR DRAWINGS

COUNCIL OFFICE - K.GURAI DH00

CLIENT: COUNCIL OFFICE

DATE: 23 - JUNE - 2022

DRAWN BY: MACO DESIGNS



Contact: 7989966, 7691671

Email: [info@maco.mv](mailto:info@maco.mv)



Contact: 7989966, 7891871  
Email: info@mamo.my

CLIENT:  
GURAIHDHO COUNCIL


PROJECT:  
GURAIHDHO  
COUNCIL OFFICE

INTERIOR DESIGN TEAM:  
SHIFAU  
NAAJIDH  
ASIF  
FAYYAH

SCALE: AS SHOWN  
DRAWING TITLE: AS SHOWN  
DATE: 2023/05/22  
REVISION NO. 01

REVISIONS:  
NO. DATE BY  
01 2023/05/22 SHIFAU

REVISIONS:  
NO. DATE BY  
01 2023/05/22 SHIFAU

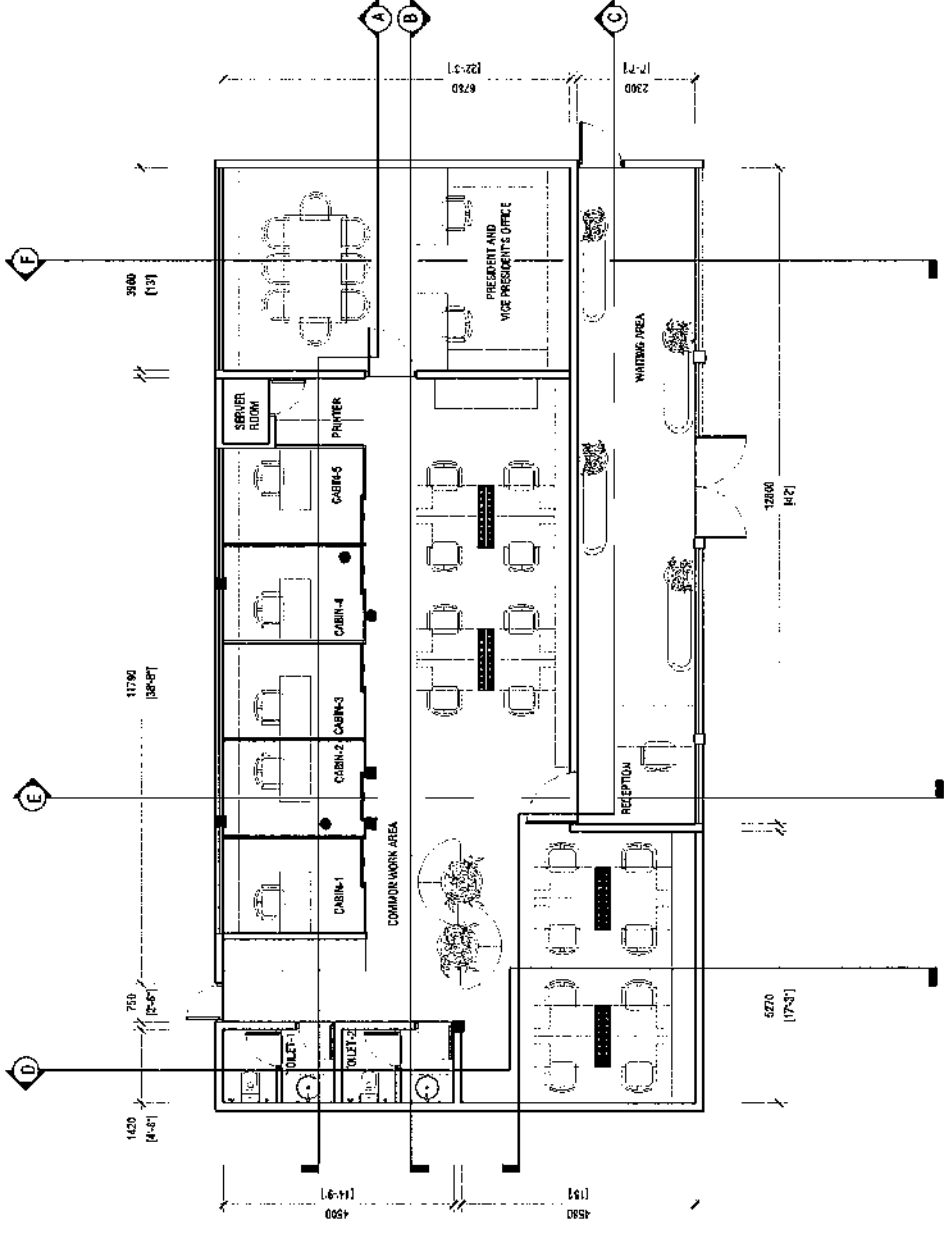

FLOOR PLAN  
GURAIHDHO COUNCIL OFFICE  
SCALE 1:100

**AMCO**  
DESIGNS  
Contact: 7989966, 7691871  
Email: info@amco.dubai.ae


CLIENT:  
**GURAIHOO COUNCIL**

PROJECT:  
**GURAIHOO COUNCIL OFFICE**

INTERIOR DESIGN TEAM:  
SHIFAU  
NAAJIDH  
ASIF  
FATYAH

SCALE: AS GIVEN  
DRAWING TITLE: AS GIVEN  
DATE: 02/08/2022  
REVISION NO.: 06  
FILE NAME: 031812022\_01\_AMCO PROJECT GURAIHOO COUNCIL OFFICE  
WARNING:

**ID02**

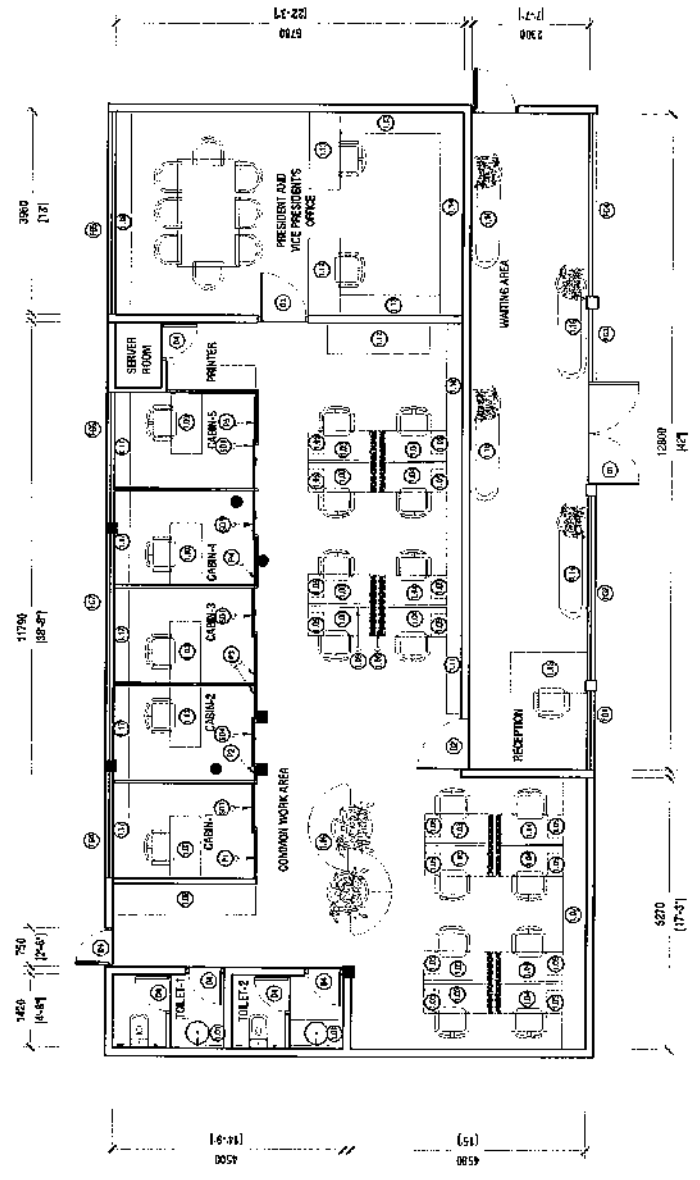

**FURNITURE LAYOUT PLAN**  
**GURAIHOO COUNCIL OFFICE**  
SCALE 1:100

**MAACO**  
DESIGNS

Contact: 79659566, 7691671  
Email: info@maaco.my

CLIENT  
GURADHOO COUNCIL

PROJECT:  
GURADHOO  
COUNCIL OFFICE

INTERIOR DESIGN TEAM  
SHIFALU  
NAAJIDH  
ASIF  
FAYYAH

SCALE: AS GIVEN

DRIVING TITLE: AS GIVEN


DATE: DECEMBER 22

DESIGNER: M.O. NO

FILE NAME:  
NAME OF ORGANIZATION: MAACO  
PROJECT: GURADHOO COUNCIL OFFICE  
DRAWING NO: 1003

WARNING:  
THIS DRAWING IS THE PROPERTY OF MAACO  
DESIGNS. IT IS TO BE USED ONLY FOR THE  
PROJECT AND SITE SPECIFICALLY MENTIONED  
HEREIN. ANY REUSE OR MODIFICATION  
WITHOUT THE WRITTEN PERMISSION OF  
MAACO DESIGNS IS STRICTLY PROHIBITED.

**ID03**

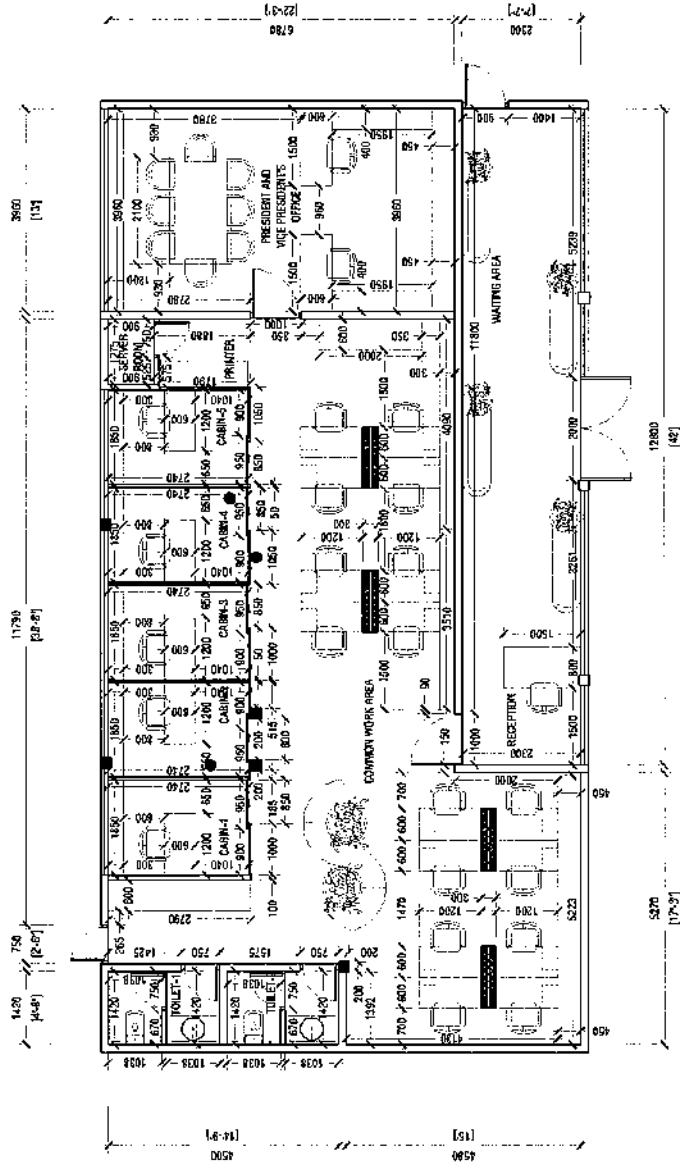

**DIMENSION PLAN**  
GURADHOO COUNCIL OFFICE  
SCALE 1:100

**AMCO**  
**DESIGNS**  
 Contact: 7999966, 7691671  
 Email: info@amco.my


CLIENT:  
**GURAIHOO COUNCIL**  
 PROJECT:  
**GURAIHOO COUNCIL OFFICE**

INTERIOR DESIGN TEAM  
 SHIFALU  
 NAJIDH  
 ASIF  
 FAYYAH

SCALE: AS SHOWN  
 DRAWING TITLE: AS GVN  
 DATE: 02/06/2023  
 DESIGNING: GP  
 FILE NAME:  
 G:\AMCO\INTERIOR\GURAIHOO COUNCIL OFFICE

WARNING:  
 THIS DRAWING IS THE PROPERTY OF AMCO DESIGNS. IT IS TO BE USED ONLY FOR THE PROJECT AND SITE SPECIFICALLY MENTIONED. IT IS NOT TO BE REPRODUCED OR TRANSMITTED IN ANY FORM OR BY ANY MEANS, ELECTRONIC OR MECHANICAL, WITHOUT THE WRITTEN PERMISSION OF AMCO DESIGNS.

**ID04**

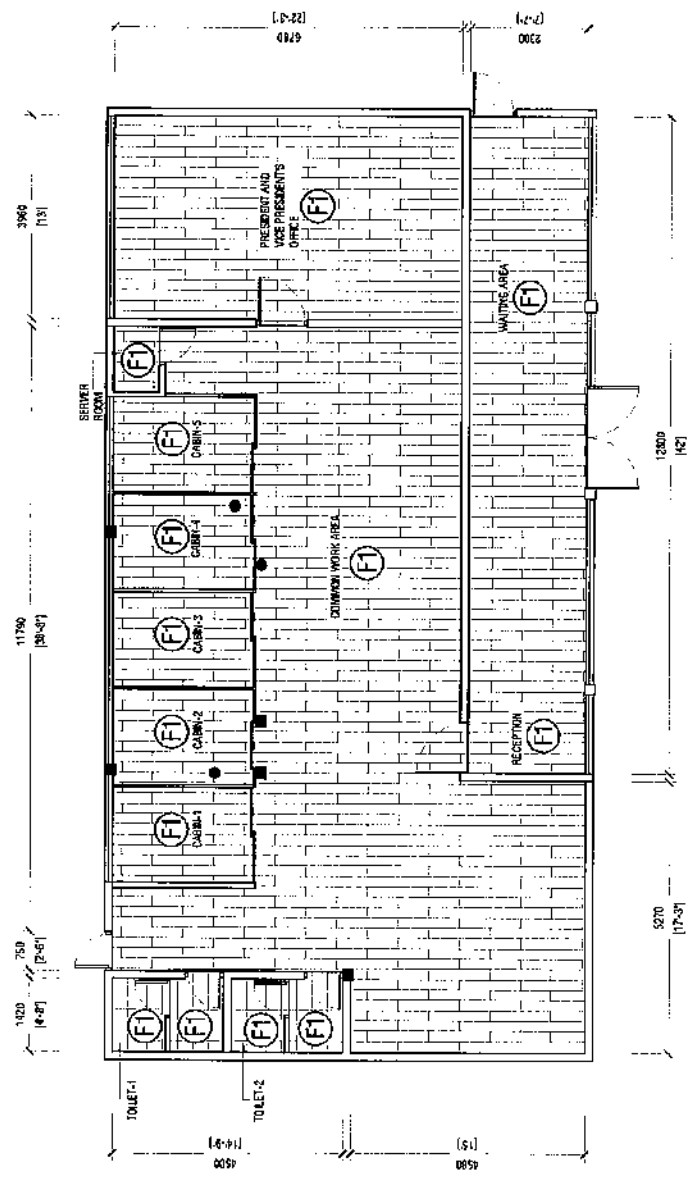

LEGEND	
SYMBOL	DESCRIPTION
(F1)	LIGHT GREY PARQUET FLOORING
(F2)	300x600 MM RUSTIC SLATE TILES

**FLOOR FINISH PLAN**  
 GURAIHOO COUNCIL OFFICE  
 SCALE 1:100

**AMCO**  
DESIGNS  
Contact: 7985966, 76591677  
Email: info@amco.com

CLIENT:  
GURADHOO COUNCIL

PROJECT:  
GURADHOO COUNCIL OFFICE

INTERIOR DESIGN TEAM:  
SHIFAU  
MAJIDH  
ASIF  
FAYYAH

SCALE AS SHOWN

DRIVING TITLE: AS GIVEN


DATE: 02/04/2022

REVISION: 00

FILE NAME:  
GURADHOO\_COUNCIL\_OFFICE  
PROJECT\_LOCATION  
CONSULTANT

WARNING:  
THIS DRAWING IS THE PROPERTY OF AMCO DESIGNS AND IS NOT TO BE REPRODUCED OR COPIED IN ANY MANNER WITHOUT THE WRITTEN PERMISSION OF AMCO DESIGNS.

**ID05**

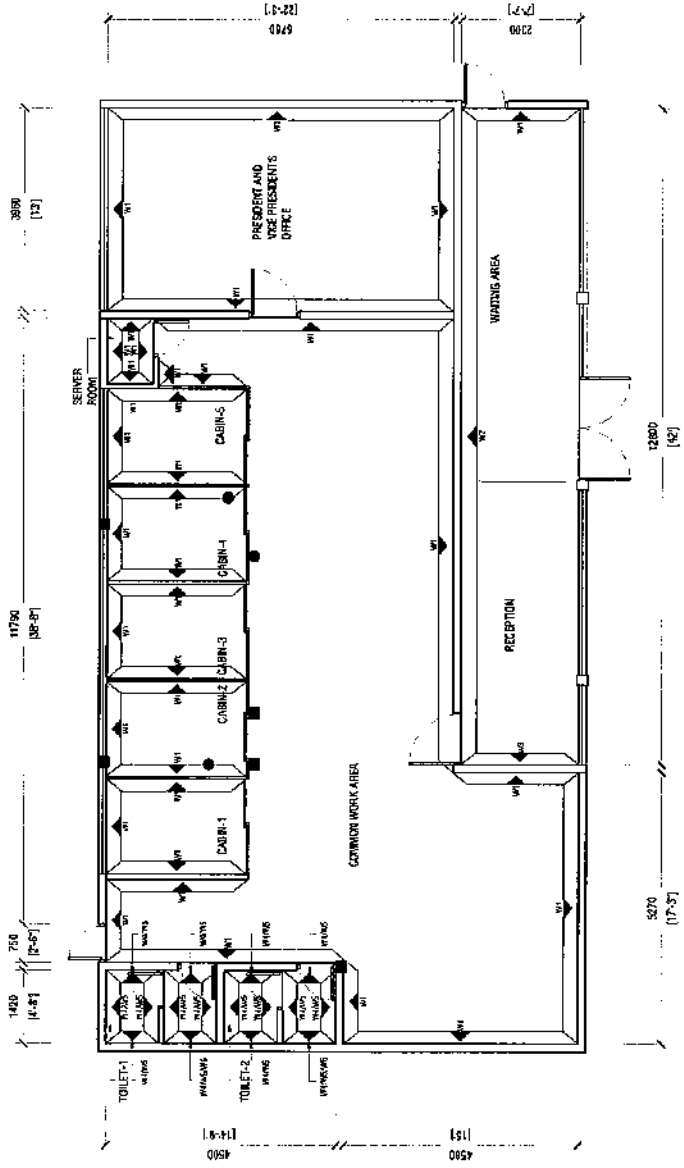

SYMBOL	DESCRIPTION
W1	MATTE WHITE WALL PAINT (SHERWIN WILLIAMS -ALABASTER (SW 7008))
W2	WALL PAPER -1
W3	WALL PAPER -2
W4	300MM X 600MM TERRAZO TILES -1(BEIGE)
W5	300MM X 600MM TERRAZO TILES -2(GREEN)
W6	SEMI GLOSS GREEN PAINT (SHERWIN WILLIAMS -TALIPOT PALM (SW 6726))

**WALL FINISH PLAN**  
GURADHOO COUNCIL OFFICE  
SCALE 1:100

**AMCO**  
 DESIGN  
 CONTACT: 7969666, 7691671  
 Email: info@amco.tn

CLIENT:  
**GURAIHOO COUNCIL**

PROJECT:  
**GURAIHOO COUNCIL OFFICE**

INTERIOR DESIGN TEAM:  
 SHIFAU  
 NAJJDH  
 ASIF  
 FAYYAH


SCALE: AS SHOWN  
 DRAWING TITLE: AS GVN  
 DATE: 02/04/2022

REVISION NO.: 04

FILE NAME:  
 GURAIHOO\_COUNCIL\_OFFICE  
 PROJECT: GURAIHOO\_COUNCIL  
 COUNCIL OFFICE


WARNING:  
 THIS DRAWING IS THE PROPERTY OF AMCO DESIGN. IT IS TO BE USED ONLY FOR THE PROJECT AND SITE SPECIFICALLY MENTIONED HEREIN. IT IS NOT TO BE REPRODUCED, COPIED, OR TRANSMITTED IN ANY FORM OR BY ANY MEANS, ELECTRONIC OR MECHANICAL, WITHOUT THE WRITTEN PERMISSION OF AMCO DESIGN.

**ID06**

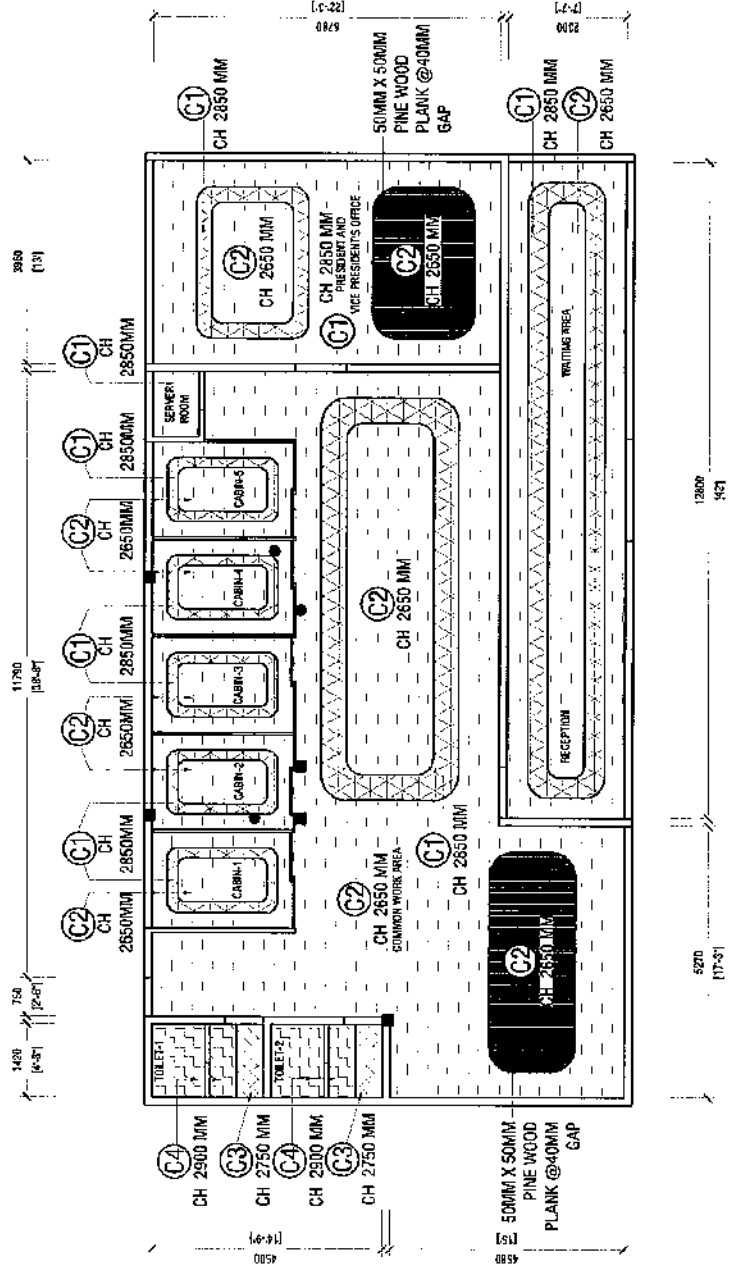

SYMBOL	HATCH	SPECIFICATION	FINISH
C1	[Hatch Pattern]	CEILING HEIGHT: 2850 MM FROM FFL	MATT WHITE PAINT
C2	[Hatch Pattern]	CEILING HEIGHT: 2650 MM FROM FFL	MATT WHITE PAINT
C3	[Hatch Pattern]	CEILING HEIGHT: 2750 MM FROM FFL	MATT WHITE PAINT
C4	[Hatch Pattern]	CEILING HEIGHT: 2900 MM FROM FFL	MATT WHITE PAINT

**CEILING FINISH PLAN**  
 GURAIHOO COUNCIL OFFICE  
 SCALE 1:100

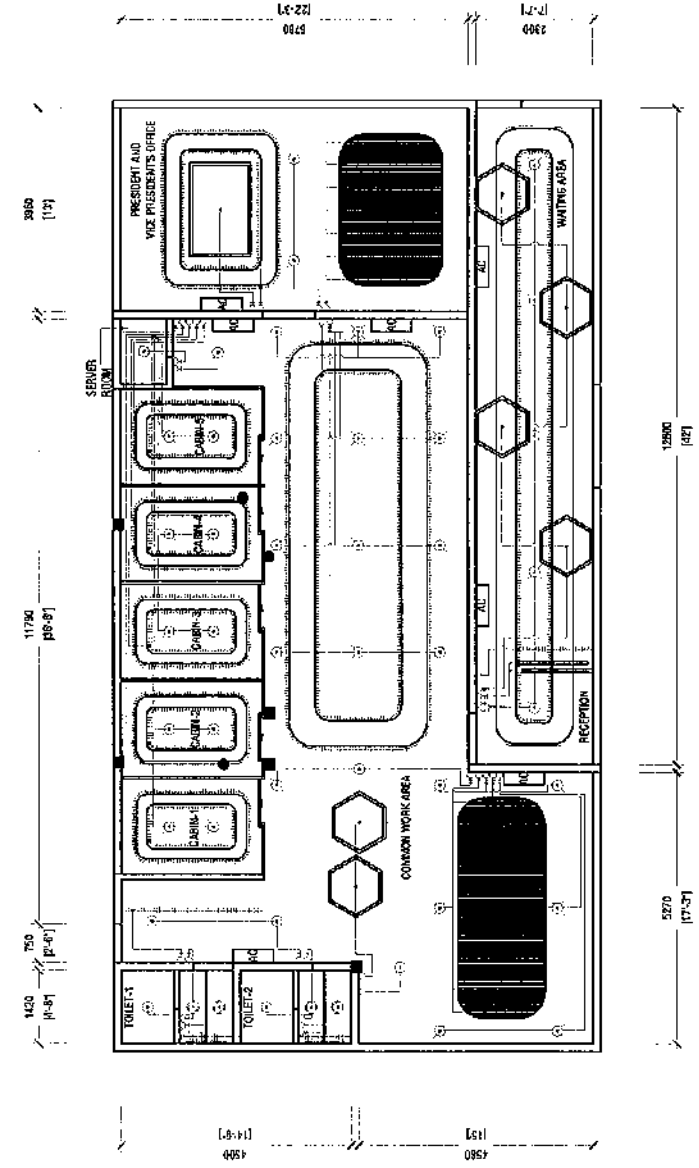

SYMBOL	DESCRIPTION
○	CEILING RECESSED LED DOWN LIGHTS
○	LED SPOT LIGHTS
○	SUSPENDED LIGHT 1
○	SUSPENDED LIGHT 2
○	SUSPENDED LIGHT 3
○	LED STRIP CEILING LIGHT
○	LED STRIP LIGHT
○	1-GNG 1-WAY LIGHT SWITCH
○	2-GNG 1-WAY LIGHT SWITCH
○	4-GNG 1-WAY LIGHT SWITCH

- ALL SWITCHES TO BE INSTALLED AT 1200 MM ABOVE FINISHED FLOOR UNLESS OTHERWISE STATED
- AFF = ABOVE FINISHED FLOOR

**LIGHTING PLAN**  
GURAIHOO COUNCIL OFFICE  
SCALE 1:100



**MACO**  
 D E S I G N S  
 Contact: 7988966, 7991671  
 Email: info@maco.my

CLIENT  
**GURAIIDHOO COUNCIL**

PROJECT  
**GURAIIDHOO COUNCIL OFFICE**


INTERIOR DESIGN TEAM  
 SHIFAU  
 MAALIDH  
 ASIF  
 FAYYAH

SCALE: AS GIVEN  
 DRAWING TITLE: AS GIVEN  
 DATE: 23/04/22  
 REVISION NO.

FILE NAME:  
 23042022\GURAIIDHOO\_COUNCIL\_OFFICE\ID08.rvt  
 PROJECT: GURAIIDHOO COUNCIL OFFICE

WARNING:  
 THIS DRAWING IS THE PROPERTY OF MACO DESIGN AND CONSULTANTS. IT IS TO BE USED ONLY FOR THE PROJECT AND SITE SPECIFICALLY MENTIONED HEREIN. IT IS NOT TO BE REPRODUCED, COPIED, OR TRANSMITTED IN ANY FORM OR BY ANY MEANS, ELECTRONIC OR MECHANICAL, WITHOUT THE WRITTEN PERMISSION OF MACO DESIGN AND CONSULTANTS.

**ID08**

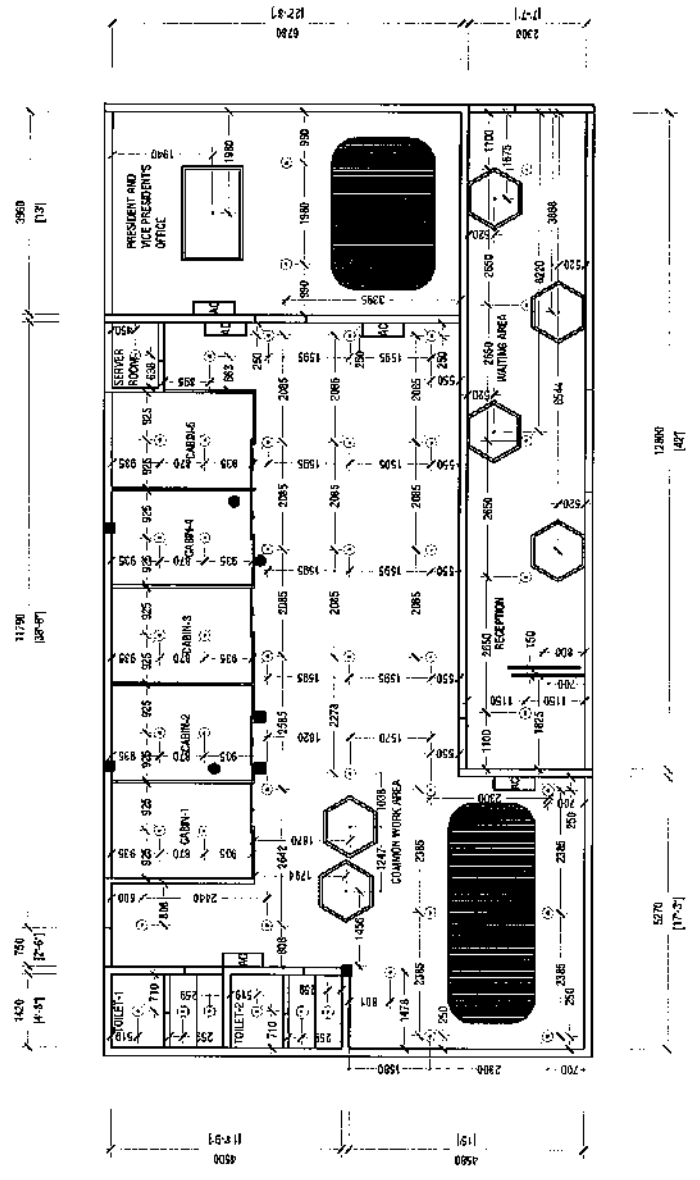

LEGEND	SYMBOL	DESCRIPTION
	○	CEILING RECESSED LED DOWN LIGHTS
	●	LED SPOT LIGHTS
	□	SUSPENDED LIGHT 1
	◻	SUSPENDED LIGHT 2
	⊠	LED STRIP CEILING LIGHT

**LIGHTING DIMENSION PLAN**  
 GURAIIDHOO COUNCIL OFFICE  
 SCALE 1:100

**AMCO**  
DESIGNS

Contact: 7989986, 7691671  
Email: info@amco.mv

CLIENT:  
GURAIHOO COUNCIL

PROJECT:  
GURAIHOO  
COUNCIL OFFICE


INTERIOR DESIGN TEAM  
SHIFAU  
NAAJIDH  
ASIF  
FAYYAH

SCALE: AS GIVEN  
DRAWING TITLE: AS GIVEN  
DATE: 02/08/2022  
REVISION NO. 01

FILE NAME:  
AMCO\GURAIHOO\GURAIHOO  
PROJECT\GURAIHOO  
COUNCIL OFFICE

WARNINGS:  
NO TEXT OR DIMENSIONS  
FOUND IN THIS DRAWING

ID09

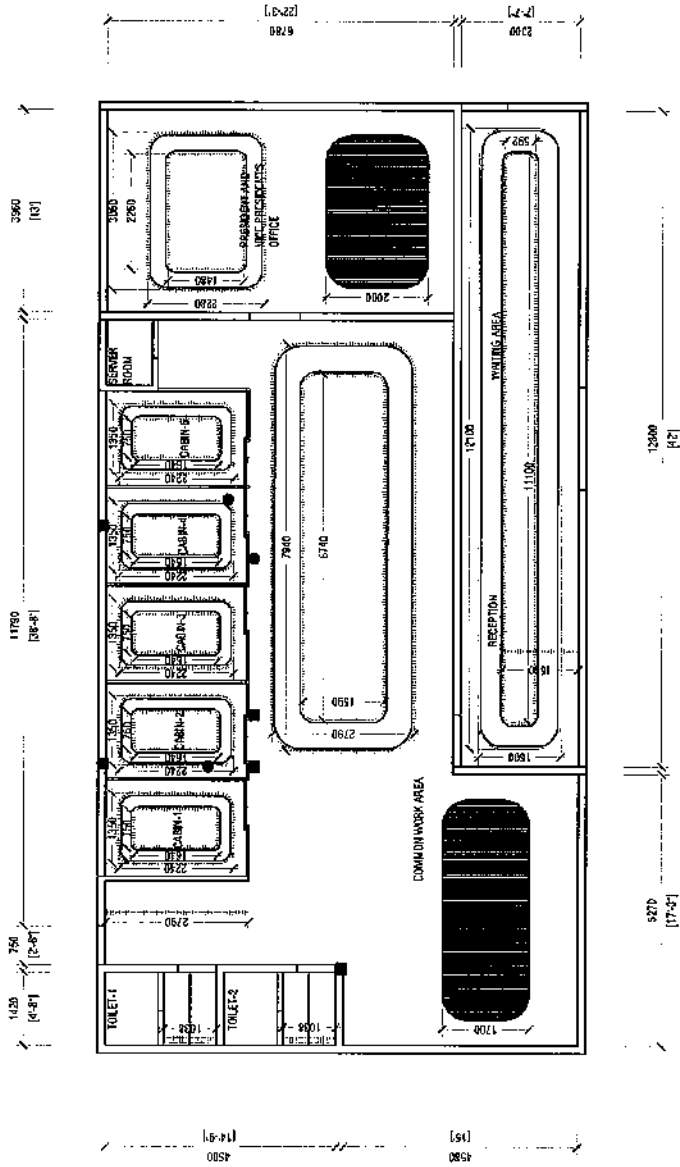

LEGEND	SYMBOL	DESCRIPTION
		LED STRIP LIGHT

LED STRIP DIMENSION PLAN  
GURAIHOO COUNCIL OFFICE  
SCALE: 1:100

**MACO**  
**D E S I G N S**  
 Contact: 7889996, 7891071  
 Email: info@maco.my

CLIENT:  
**GURAIHOO COUNCIL**


PROJECT:  
**GURAIHOO COUNCIL OFFICE**

INTERIOR DESIGN TEAM:  
 SHIFALU  
 MAALUDH  
 ASIF  
 FAYYAH

SCALE: AS GIVEN  
 DRAWING TITLE: AS GIVEN  
 DATE: 02/06/2022  
 REVISIONING: ID  
 FILE NAME:  
 PROJECT: GURAIHOO\_COUNCIL\_OFFICE  
 PROJECT: GURAIHOO\_COUNCIL\_OFFICE  
 PROJECT: GURAIHOO\_COUNCIL\_OFFICE  
 PROJECT: GURAIHOO\_COUNCIL\_OFFICE

WARNING:  
 THIS DRAWING IS THE PROPERTY OF MACO DESIGN AND SHALL NOT BE REPRODUCED OR TRANSMITTED IN ANY FORM OR BY ANY MEANS, ELECTRONIC OR MECHANICAL, WITHOUT THE WRITTEN PERMISSION OF MACO DESIGN.

**ID10**

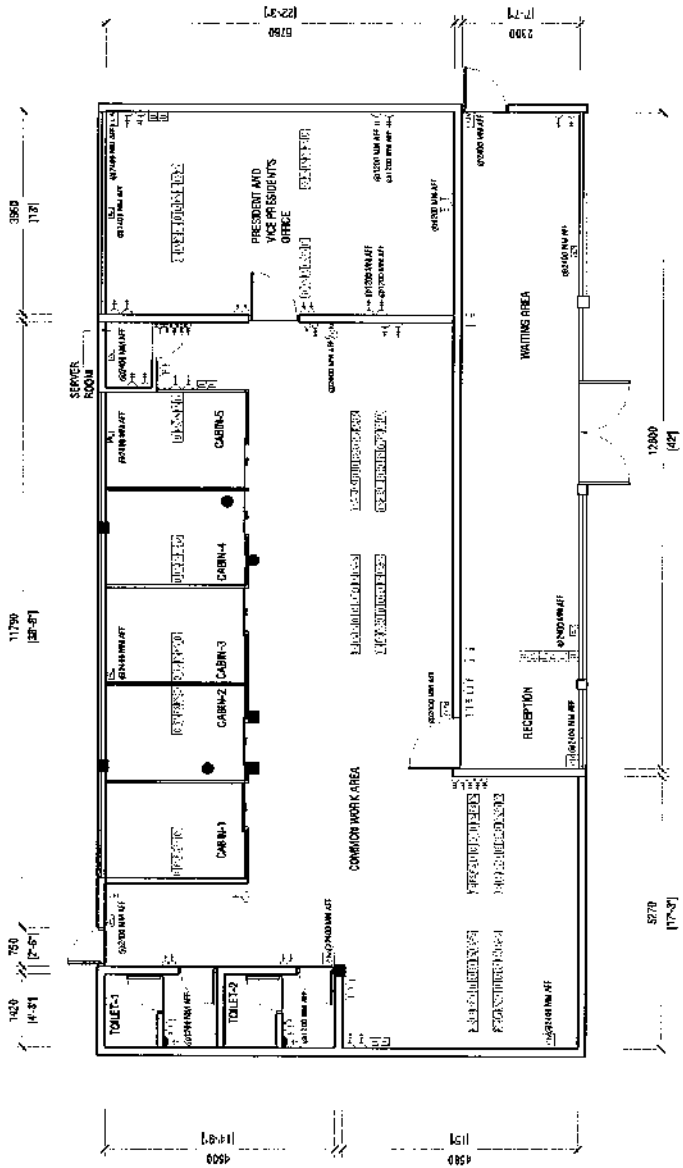


LEGEND	SYMBOL	DESCRIPTION
	○	SINGLE GANG SOCKET
	○	DOUBLE GANG SOCKET
	○	WATER PROOF SINGLE GANG SOCKET
	○	FLOOR SOCKET
	○	DATA POINT
	○	AC POINT
	○	1-GANG 1-WAY LIGHT SWITCH
	○	2-GANG 1-WAY LIGHT SWITCH
	○	4-GANG 1-WAY LIGHT SWITCH
	○	CCTV CONNECTION POINT


- ALL SOCKETS TO BE INSTALLED AT 300 MM ABOVE FINISHED FLOOR UNLESS OTHERWISE STATED
- ALL SWITCHES TO BE INSTALLED AT 1200 MM ABOVE FINISHED FLOOR UNLESS OTHERWISE STATED
- AFF = ABOVE FINISHED FLOOR

**POWER LAYOUT PLAN**  
 LINE GROUND FLOOR  
 SCALE 1:100


- NOTE
- SL = SLAB LINE
  - CL = CEILING LINE
  - DCL = DROP CEILING LINE
  - RFEL = RAISED FLOOR FINISH LINE
  - FFL = FLOOR FINISH LINE

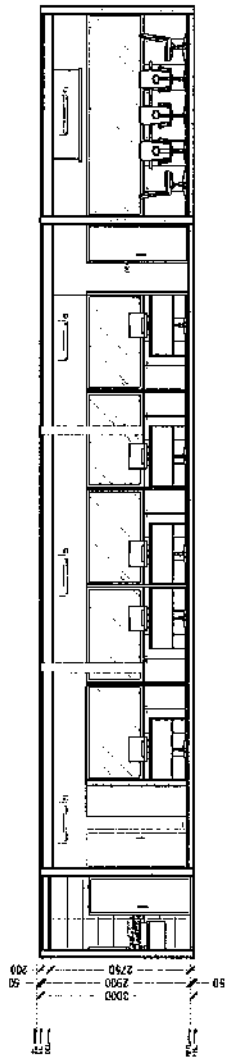

SECTIONAL ELEVATION A

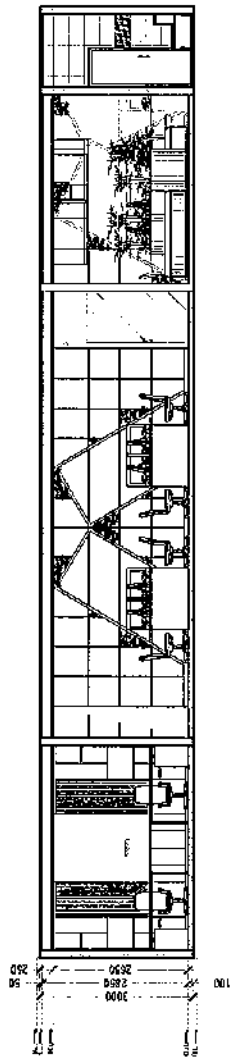

SECTIONAL ELEVATION B

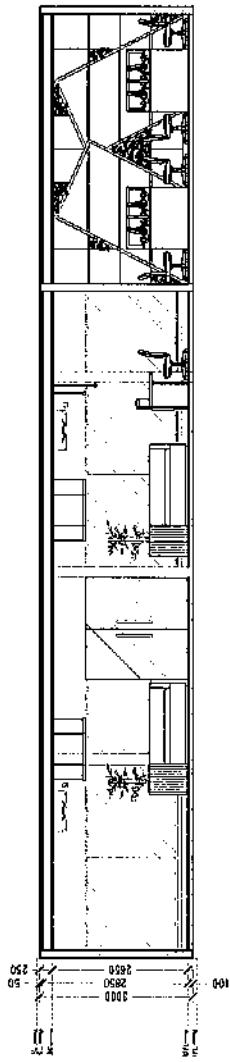

SECTIONAL ELEVATION C

SECTIONAL ELEVATION A, B & C  
 GURAIIDHOO COUNCIL OFFICE  
 SCALE 1:100

- NOTE
- ALL WALLS FINISHED IN MATT WHITE PAINT REF 5.03/01 UNLESS SPECIFIED OTHERWISE
  - WOOD SKIRTING FINISHED IN WHITE MATT PAINT REF 5.03 IN ALL AREAS

**MACO**  
 D E S I G N S  
 Contact: 79699988, 7691671  
 Email: info@maco.mv

CLIENT  
 GURAIIDHOO COUNCIL

PROJECT  
 GURAIIDHOO COUNCIL OFFICE

INTERIOR DESIGN TEAM  
 SHIFRAU  
 MAAJIDH  
 ASIF  
 FAYYAH

SCALE: AS SHOWN  
 DRAWING TITLE: AS GIVEN  
 DATE: 04/05/2024  
 REVISION NO. 00


FILE NAME: 20240405\_0001\_MACO  
 PROJECT NUMBER: 20240405\_0001  
 CLIENT: GURAIIDHOO COUNCIL OFFICE

WARNING:  
 THIS DRAWING IS THE PROPERTY OF MACO DESIGN AND ARCHITECTURE. IT IS TO BE USED ONLY FOR THE PROJECT AND SITE SPECIFICALLY IDENTIFIED HEREIN. IT IS NOT TO BE REPRODUCED, COPIED, OR TRANSMITTED IN ANY FORM OR BY ANY MEANS, WITHOUT THE WRITTEN PERMISSION OF MACO DESIGN AND ARCHITECTURE.


ID11

NOTE

- SL = SLAB LINE
- CL = CEILING LINE
- DCL = DROP CEILING LINE
- RFFL = RAISED FLOOR FINISH LINE
- FFL = FLOOR FINISH LINE

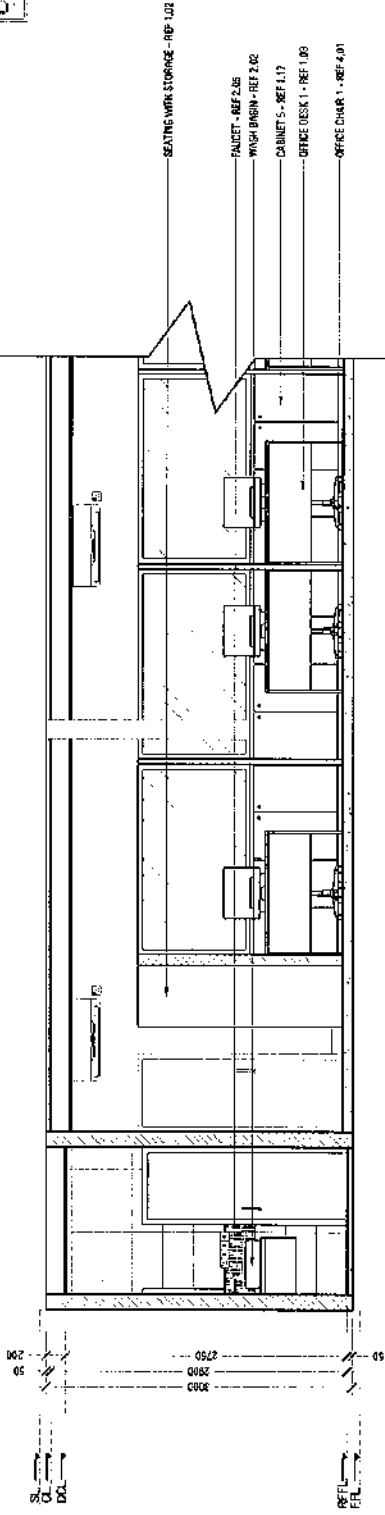


SECTIONAL ELEVATION A

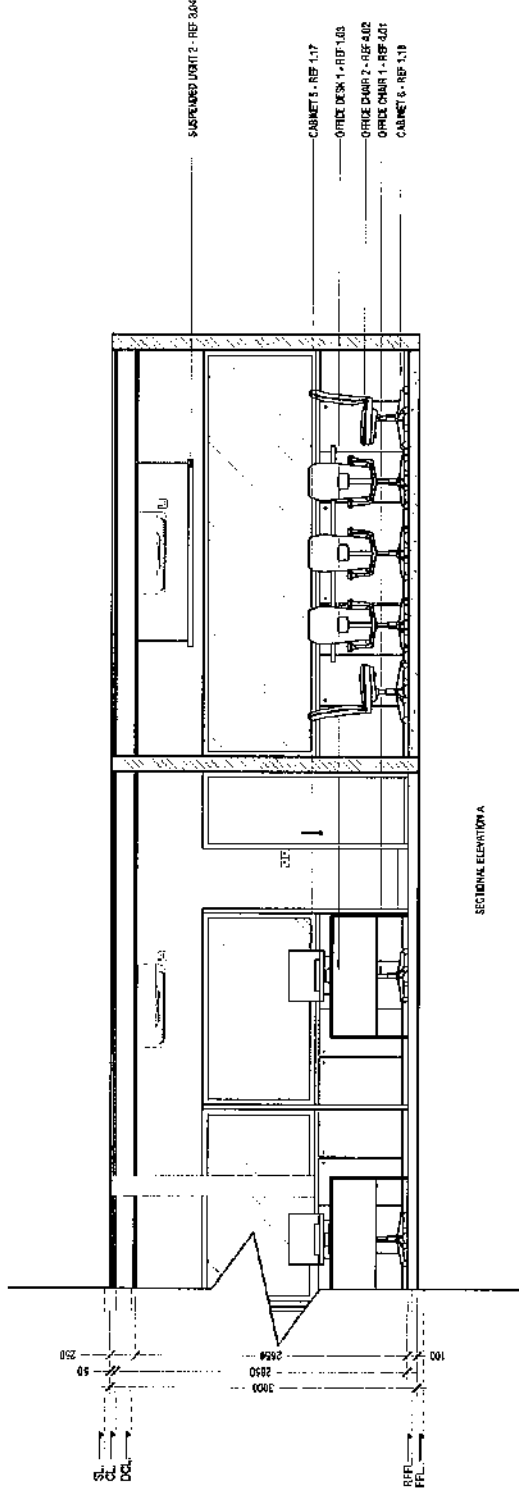

SECTIONAL ELEVATION A

NOTE

- ALL WALLS FINISHED IN MATT WHITE PAINT REF 5.03(W)1 UNLESS SPECIFIED OTHERWISE
- WOOD SKIRTING FINISHED IN WHITE MATT PAINT REF 5.03 IN ALL AREAS

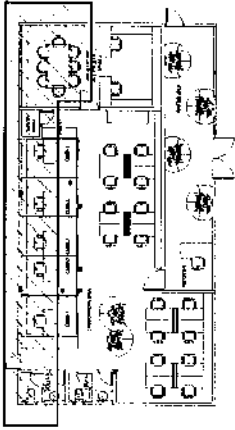

KEY PLAN

**MACO**  
DESIGNS

Contact: 79499966, 76516571  
Email: info@maco.nv

CUSTOMER:  
GURAIHOO COUNCIL

PROJECT:  
GURAIHOO COUNCIL OFFICE

INTERIOR DESIGN TEAM:  
SHIFAU  
NAALIDH  
ASIF  
FATTAH


SCALE: AS SHOWN  
DRAWING TITLE: AS SHOWN  
DATE: 23/08/22  
REVISION NO: 01  
P.L.C NAME:  
M. MOHAMMAD, M. NAALIDH, M. ASIF, M. FATTAH  
PROJECT NO: 202208040100  
DRAWN BY: M. ASIF

WARNINGS:  
THIS DRAWING IS THE PROPERTY OF MACO DESIGNS. IT IS TO BE USED ONLY FOR THE PROJECT AND SITE SPECIFICALLY MENTIONED. IT IS NOT TO BE REPRODUCED OR TRANSMITTED IN ANY FORM OR BY ANY MEANS, ELECTRONIC OR MECHANICAL, WITHOUT THE WRITTEN PERMISSION OF MACO DESIGNS.


ID12

SECTIONAL ELEVATION A  
SCALE 1:50

- NOTE
- SL = SLAB LINE
  - CL = CEILING LINE
  - DCL = DROP CEILING LINE
  - RFFL = RAISED FLOOR FINISH LINE
  - FFL = FLOOR FINISH LINE

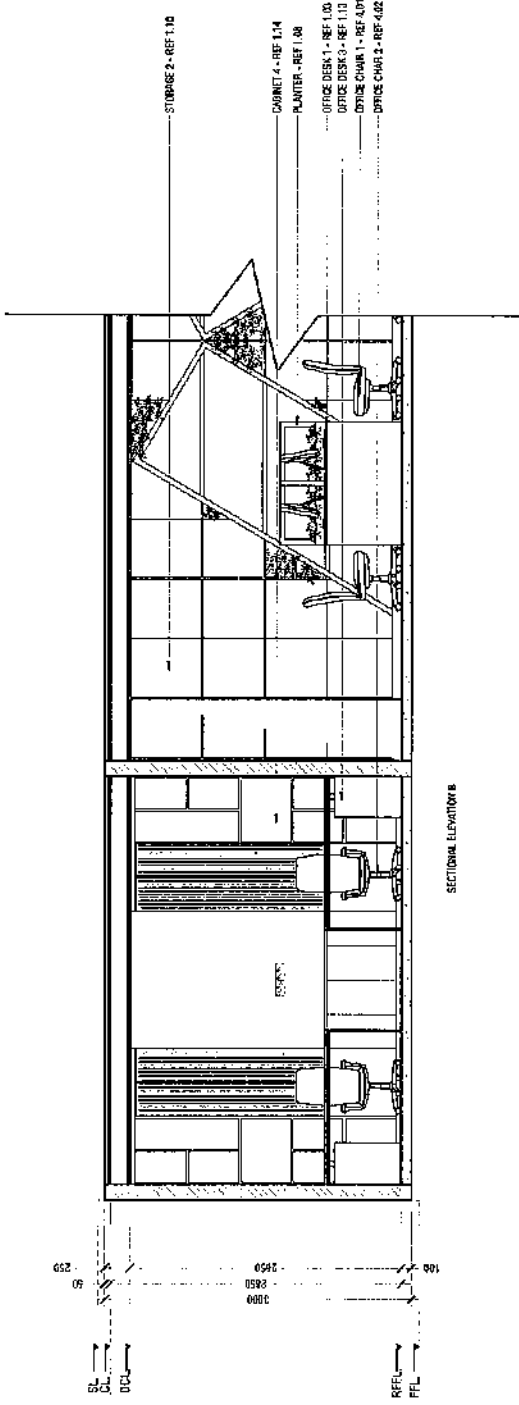

SECTIONAL ELEVATION B

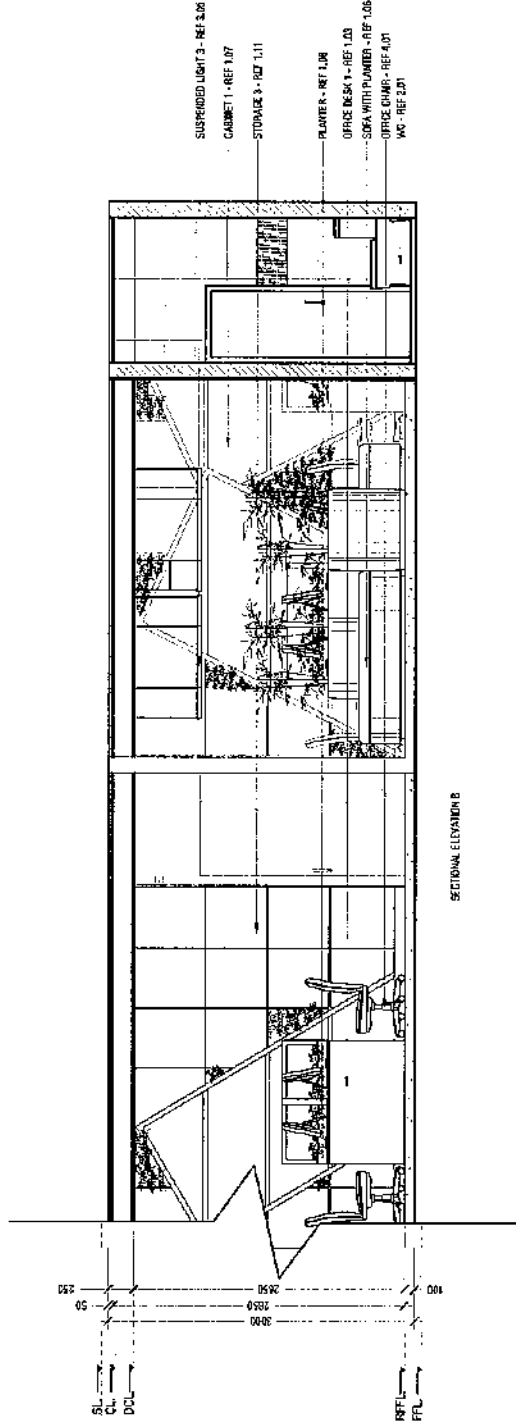


SECTIONAL ELEVATION B

NOTE

- ALL WALLS FINISHED IN MATT WHITE PAINT REF 5.03/W1 UNLESS SPECIFIED OTHERWISE
- WOOD SKIRTING FINISHED IN WHITE MATT PAINT REF 5.03 IN ALL AREAS

SECTIONAL ELEVATION B  
SCALE 1:50

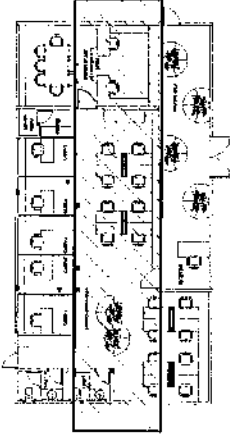

KEY PLAN

**MACO**  
DESIGNS

Contact: 79698668, 7891871  
Email: info@maco.my

CLIENT

GURAIHOO COUNCIL

PROJECT:

GURAIHOO COUNCIL OFFICE

INTERIOR DESIGN TEAM

SHIFALU

NAALJIDH

ASIF

FAYYAH

SCALE: AS GIVEN

DRAWING TITLE: AS GIVEN

DATE: 02/06/2022

REVISION NO: 00

FILE NAME



\\MACO\PROJECTS\GURAIHOO\_COUNCIL\_OFFICE\PROJECT\02062022\02062022.DWG

PROJECT: GURAIHOO COUNCIL OFFICE

WARNING:


ID13

- NOTE
- SL = SLAB LINE
  - CL = CEILING LINE
  - DCL = DROP CEILING LINE
  - RFFL = RAISED FLOOR FINISH LINE
  - FFL = FLOOR FINISH LINE

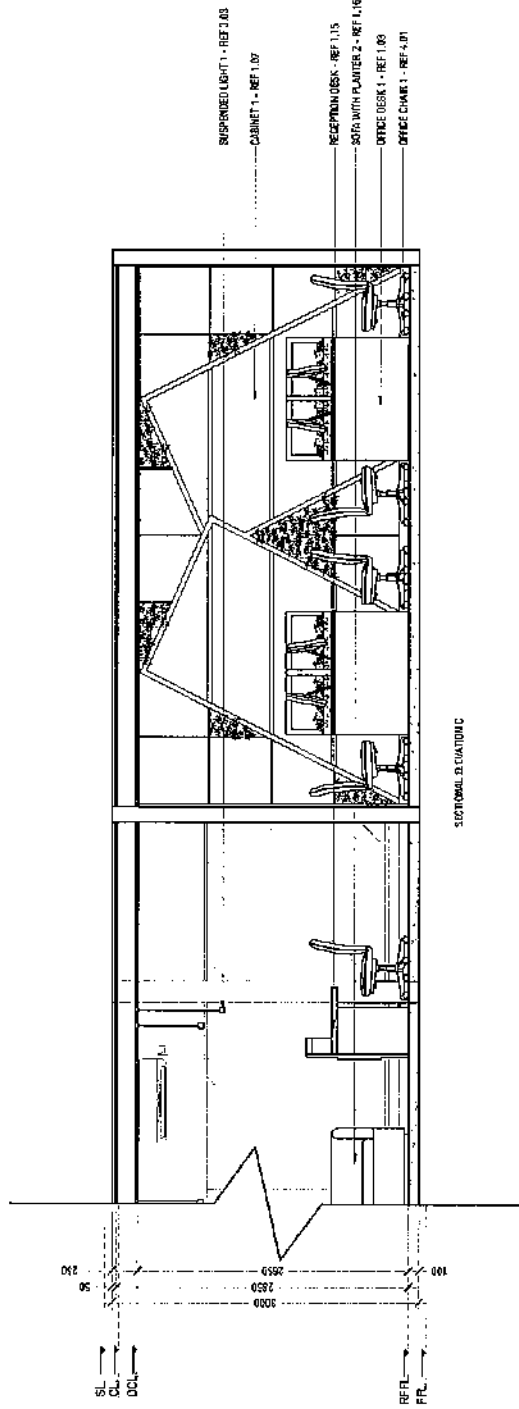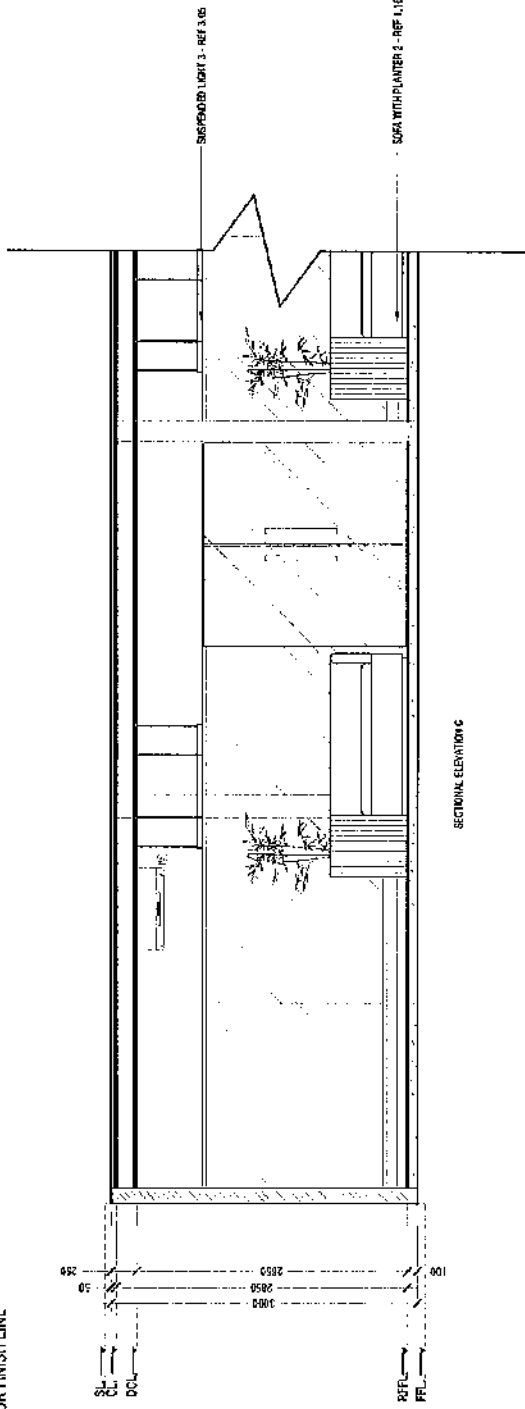

- NOTE
- ALL WALLS FINISHED IN MATT WHITE PAINT REF 5.03(W1) UNLESS SPECIFIED OTHERWISE
  - WOOD SKIRTING FINISHED IN WHITE MATT PAINT REF 5.03 IN ALL AREAS

**SECTIONAL ELEVATION C**  
**SCALE 1:50**

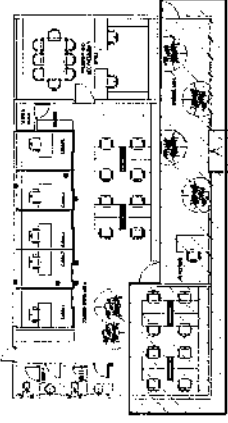

KEY PLAN

**AMACO**  
**DESIGNS**

Contact: 7988666, 7981671  
 Email: info@amaco.my

CLIENT:

GURAIHDOO COUNCIL

PROJECT:

GURAIHDOO COUNCIL OFFICE

INTERIOR DESIGN TEAM  
 SHIFALU  
 MAJIDH  
 ASIF  
 FATYAH

SCALE AS SHOWN

DRAWING TITLE: AS SHOWN

DATE DRAWING: 23


REVISION NO. 00

FILE NAME:

A:\Users\shifal@amaco.my\My Documents\GURAIHDOO COUNCIL OFFICE

WORKING

ID14

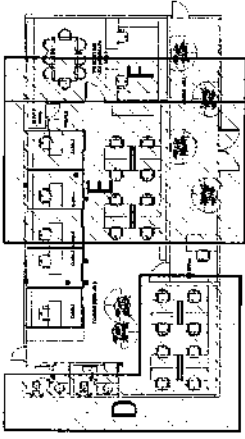

**KEY PLAN**

- NOTE**
- SL = SLAB LINE
  - CL = CEILING LINE
  - DCL = DROP CEILING LINE
  - RFL = RAISED FLOOR FINISH LINE
  - FFL = FLOOR FINISH LINE

**AMACO**

**D E S I G N S**

Contact: 7969606, 7691671

Email: info@amaco.nv

CLIENT:

GURAIHOO COUNCIL

PROJECT:

GURAIHOO COUNCIL OFFICE

MEMBER DESIGN TEAM:

SHIFAU

NAAJIDH

ASIF

FAYYAH

SCALE: AS SHOWN

DRAWING TITLE: AS GRN

DATE: 02/04/2022

PROJECT NO.

FILE NAME

PROJECT LOCATION: NINGAO

PROJECT NO: 2022/02/04/00

DATE: 02/04/2022

DRAWING NO.

SCALE: AS SHOWN

PROJECT NO.

FILE NAME

PROJECT LOCATION: NINGAO

PROJECT NO: 2022/02/04/00

DATE: 02/04/2022

DRAWING NO.

SCALE: AS SHOWN

PROJECT NO.

FILE NAME


PROJECT LOCATION: NINGAO

PROJECT NO: 2022/02/04/00


DATE: 02/04/2022

DRAWING NO.


**ID15**

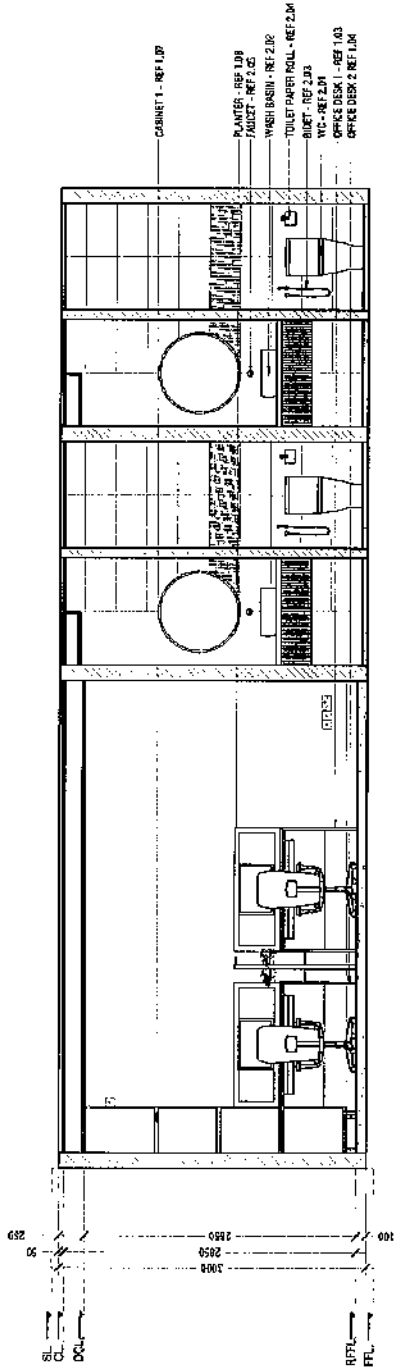

SECTIONAL ELEVATION D

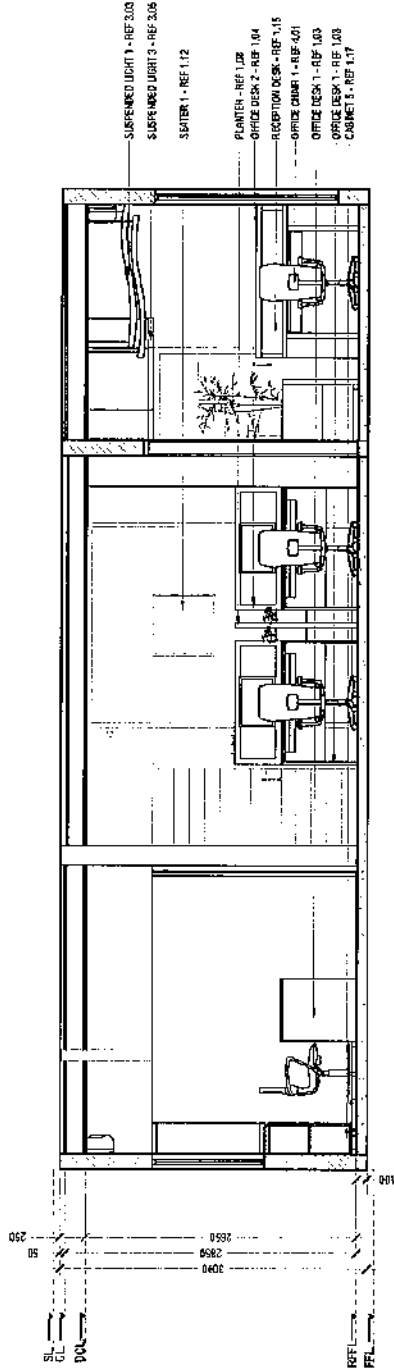

SECTIONAL ELEVATION E

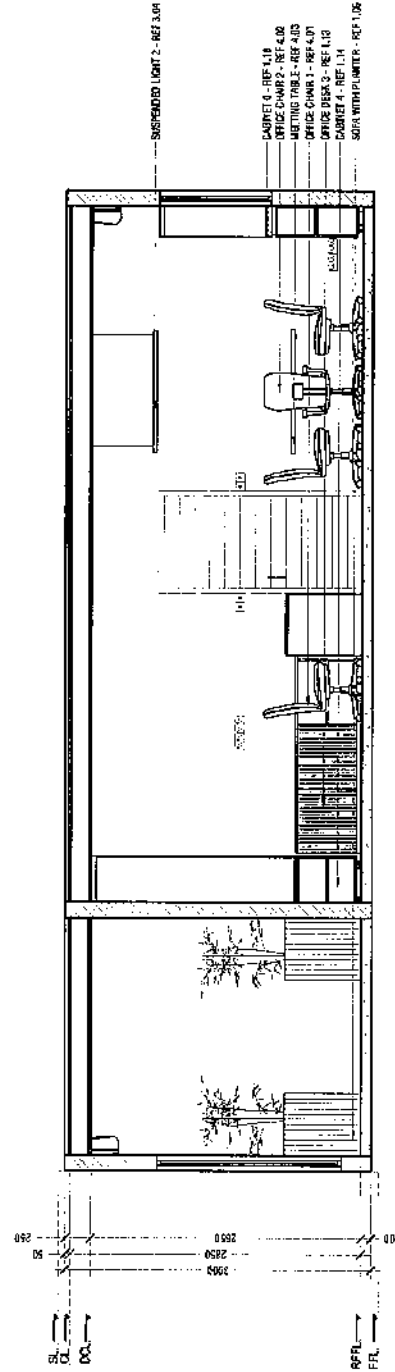

SECTIONAL ELEVATION F

**NOTE**


- ALL WALLS FINISHED IN MATT WHITE PAINT REF 5.03/011 UNLESS SPECIFIED OTHERWISE
- WOOD SKIRTING FINISHED IN WHITE MATT PAINT REF 5.03 IN ALL AREAS

**SECTIONAL ELEVATION D, E, & F**  
**SCALE 1:50**



NOTE

- CL = CEILING LINE
- DCL = DROP CEILING LINE
- FFL = FLOOR FINISH LINE
- RFFL = RAISED FLOOR LINE

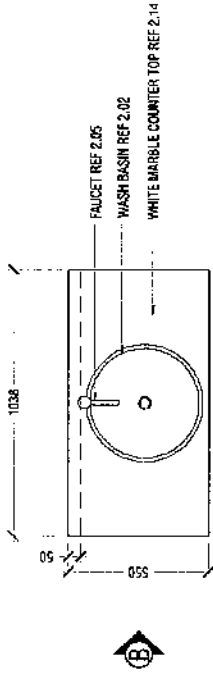

PLAN

**AMACO**  
DESIGNS  
Contact: 7989866, 7691871  
Email: info@amaco.my

CLIENT:  
JAUFAR RASHEED

PROJECT:  
LUCKYLAST

AA: UKULHAS

INTERIOR DESIGNER TEAM:  
NAAJID  
ASIF  
FAYYAH  
NILOCFAR

SCALE: AS GIVEN


DRAWING TITLE: AS GIVEN

DATE: 23/08/2021


REVISION NO.: 00

FILE NAME:  
YOUKASABO/WATER/AMACO  
PROJECTS/INTERIOR PROJECTS  
2021/PROJECT/PLAN/AA

WARNING:  
THIS DRAWING IS THE PROPERTY OF AMACO DESIGNS. IT IS TO BE USED ONLY FOR THE PROJECT AND SITE SPECIFICALLY MENTIONED HEREIN. IT IS NOT TO BE REPRODUCED, COPIED, OR TRANSMITTED IN ANY FORM OR BY ANY MEANS, ELECTRONIC OR MECHANICAL, INCLUDING PHOTOCOPYING, RECORDING, OR BY ANY INFORMATION STORAGE AND RETRIEVAL SYSTEM, WITHOUT THE WRITTEN PERMISSION OF AMACO DESIGNS.

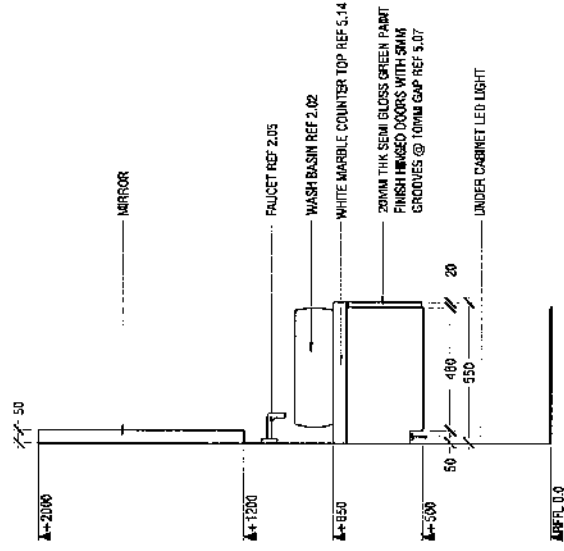

ELEVATION B

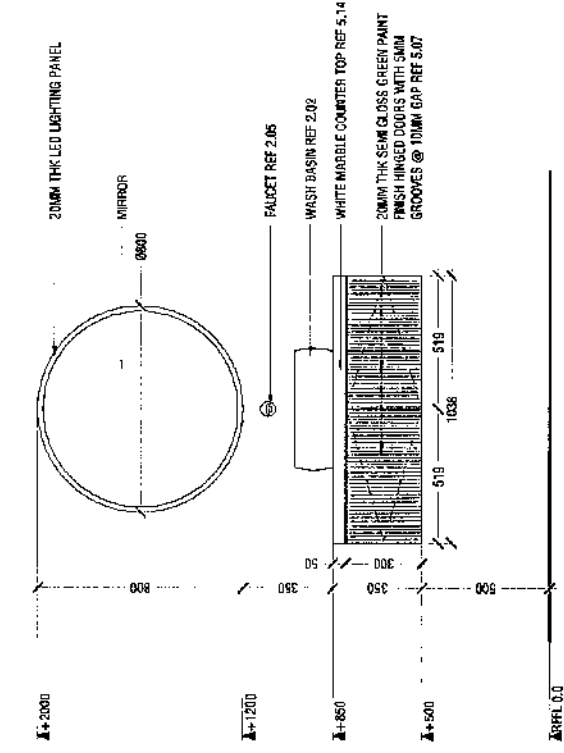


ELEVATION A

- TOP & BASE FINISHED IN MATTE WHITE LAMINATE REF 5.09
- CARCASS AND SHELVES FINISHED IN WHITE LAMINATE 5.09

1.01 VANITY CABINET & MIRROR  
SCALE 1:20

ID16

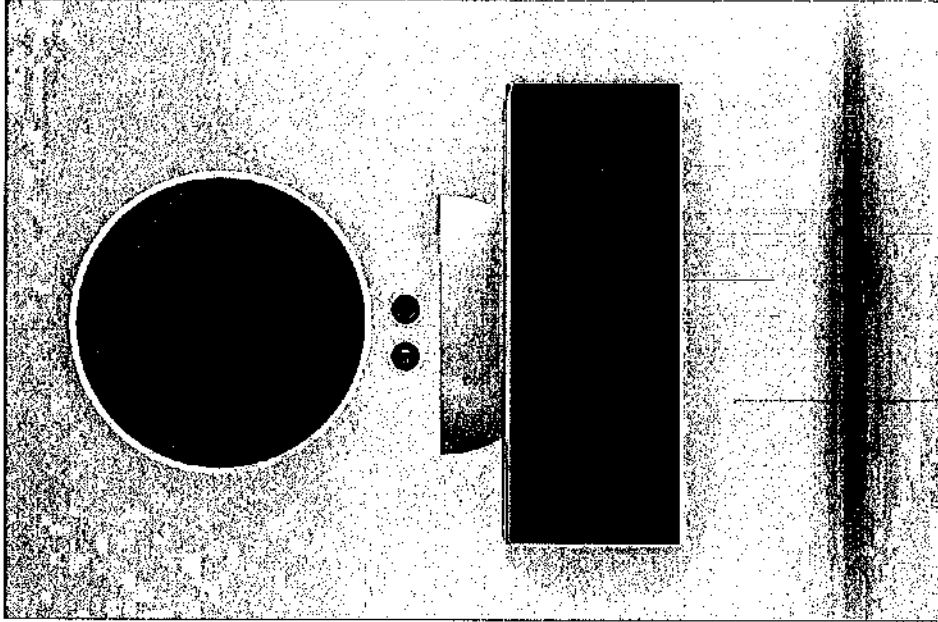

**MACO**  
DESIGNS  
Contact: 7989965, 7691671  
Email: info@maco.id

CURT

PROJECT

JAUFAR RASHEED

PROJECT

LUCKYLAST

AAJULHAS

INTERIOR DESIGNER TEAM

NAAJID

ASIF

FAYYAH

NILOOFAR

SCALE: AS SHOWN

DRAWING TITLE: AS SHOWN

DRAWN BY: JEFF

REVISION NO. 00

FILE NAME

3D RENDERING: MACO

PROJECT: INTERIOR PROJECTS

DATE: 2023-10-10

TIME: 10:00 AM

LOCATION: JAWA BARAT

CLIENT: JAWA BARAT

PROJECT NO: 001

PROJECT NAME: JAWA BARAT

PROJECT ADDRESS: JAWA BARAT

PROJECT CONTACT: JAWA BARAT


1.01 VANITY CABINET & MIRROR  
SCALE 1:20

ID17



**NOTE**

 - CL = CEILING LINE
- DCL = DROP CEILING LINE
- FFL = FLOOR FINISH LINE
- RFFL = RAISED FLOOR LINE



Contact: 7988966, 7691671  
Email: info@maco.my

CLIENT:

JAUFAR RASHEED

PROJECT:

LUCKYLAST

AAJUKULHAS

INTERIOR DESIGNER TEAM:

NAAJID  
ASIF  
FRYYAH  
NULOOFAR

SCALE: AS GIVEN

DRIVING TITLE : AS GIVEN

DATE: 02/11/2024



REVISION NO. 01

FILE NAME:

PROJECT: 7988966, 7691671

WARNING:

This drawing is the property of MACO DESIGNS and is to be used for the project specified only. It is not to be reproduced, copied, or used for any other project without the written consent of MACO DESIGNS. All dimensions are in millimeters unless otherwise specified. The contractor is responsible for ensuring that the materials and workmanship meet the requirements of this drawing and the relevant building codes. The client is responsible for providing accurate information and for any changes or variations to the project.

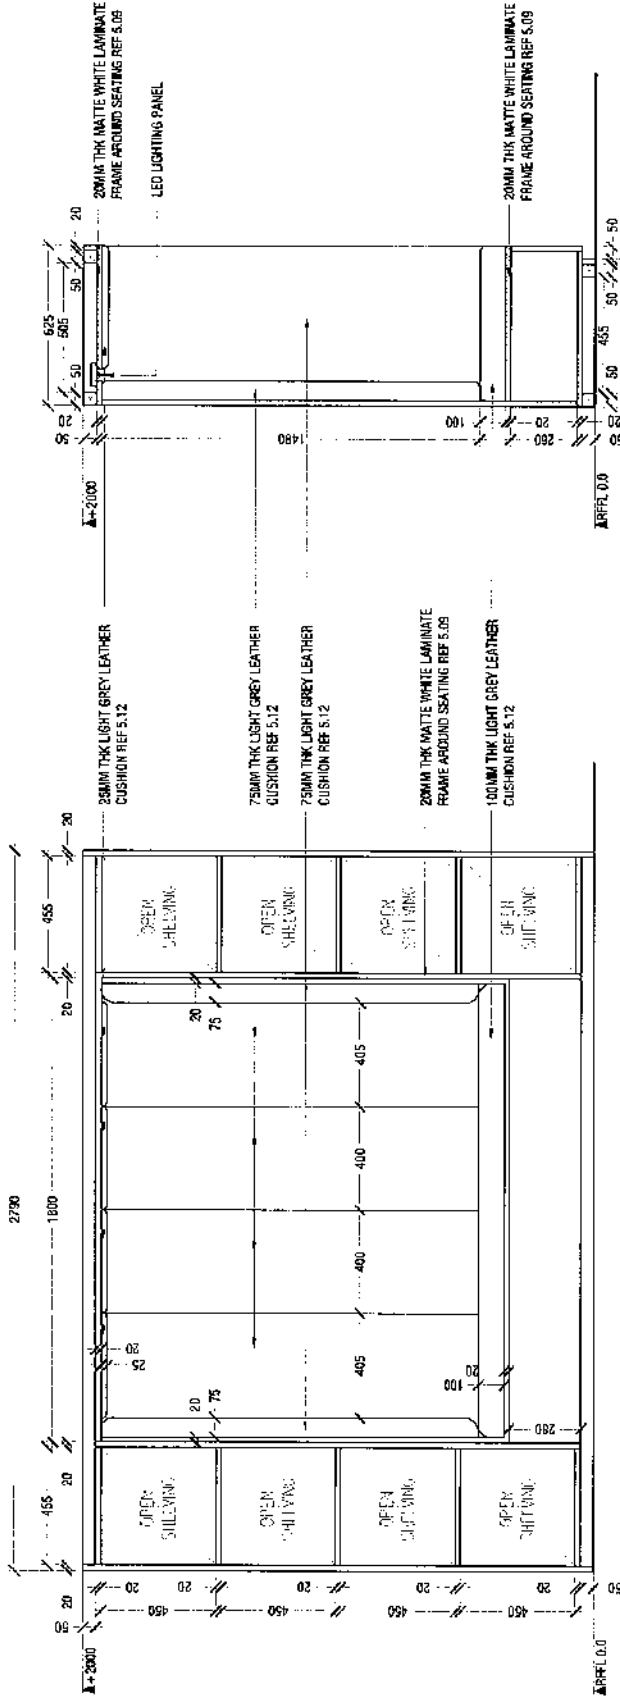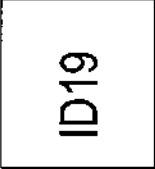

OPEN ELEVATION A

SECTION X

- TOP & BASE FINISHED IN PINE WOOD LAMINATE
- HINGE DOORS FINISHED IN MATTE WHITE LAMINATE
- CARCASS AND SHELVES FINISHED PINE WOOD LAMINATE

**MACO**  
DESIGNS

Contact: 7989966, 7691671  
Email: info@maco.my

CLIENT:

JAUFAR RASHEED

PROJECT:

LUCKYLAST

AA UKULHAS

INTERIOR DESIGNER TEAM

NAAJID

ASIF

FAYYAH

NILDOOFAR

SCALE: AS GIVEN

DRAWING TITLE : AS GIVEN

DATE: 02/07/2021

REVISION NO: 00

FILE NAME:

PROJECT/INTERIOR/PROJECTS  
LUCKYLAST/AAUKULHAS

WARNING:

THIS DRAWING IS THE PROPERTY OF MACO DESIGNS. IT IS TO BE USED ONLY FOR THE PROJECT AND SITE SPECIFICALLY MENTIONED. ANY REUSE OR MODIFICATION OF THIS DRAWING WITHOUT THE WRITTEN PERMISSION OF MACO DESIGNS IS STRICTLY PROHIBITED. ANY VIOLATION OF THIS WARNING WILL BE PROSECUTED TO THE FULL EXTENT OF THE LAW.




1.02 SEATING WITH STORAGE  
SCALE 1:20


ID20

**NOTE**


- CL = CEILING LINE
- DCL = DROP CEILING LINE
- FFL = FLOOR FINISH LINE
- RFFL = RAISED FLOOR LINE

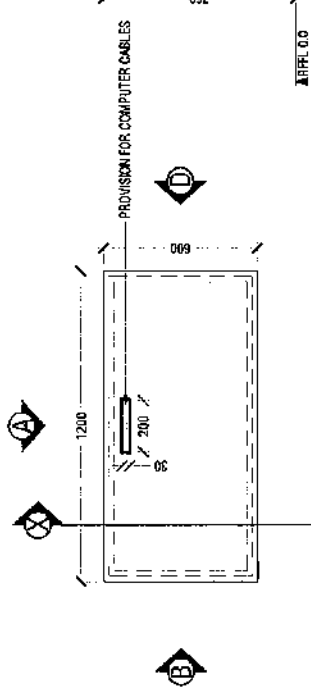


**PLAN**

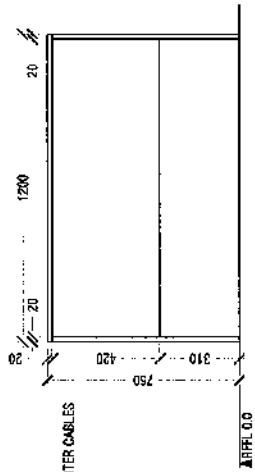


**ELEVATION A**

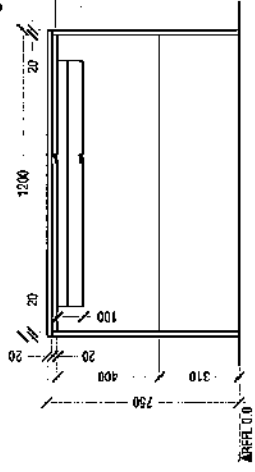


**ELEVATION C**

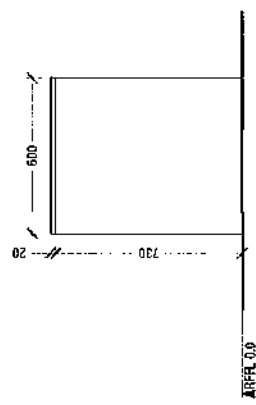

**ELEVATION B**

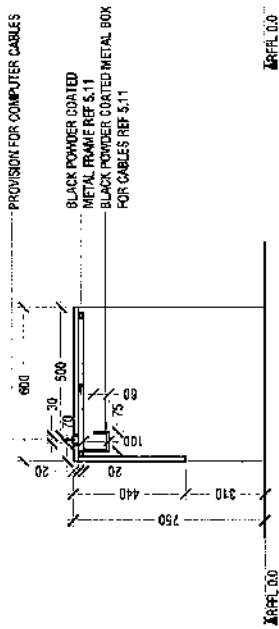

**SECTION X**

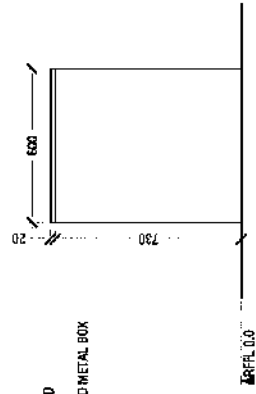

**ELEVATION D**

**AMCO**  
DESIGNS

Contact: 7969996, 7691671  
Email: info@amco.my

CLIENT:

JAUFAR RASHEED

PROJECT:

LUCKYLAST

AAJUKULHAS

INTERIOR DESIGNER TEAM

NAAJID

ASIF

FATYAH

NILOO HAR

SCALE: ADMEN

DRAWING TITLE: AS GVN

DATE: 08/02/2021

REVISION NO: 01

FILE NAME:  
C:\AMCO\BROUWER\AMCO  
PROJECTS\LUCKYLAST\LUCKYLAST

**WARNINGS**  
This drawing is the property of AMCO DESIGNS and is not to be used, copied, or reproduced in any form without the written permission of AMCO DESIGNS. All rights reserved. AMCO DESIGNS is not responsible for any errors or omissions in this drawing. The user of this drawing is advised to verify all dimensions and specifications before construction.

1.03 OFFICE DESK - 1  
SCALE 1:20

• TABLE TOP AND LEGS FINISHED IN PINE WOOD LAMINATE REF 5.08

**ID21**

**MACO**  
DESIGNS

Contact: 7989966, 7691671  
Email: info@maco.my

CLIENT:

JAUFAR RASHEED

PROJECT:

LUCKYLAST

AA LUKULHAS

INTERIOR DESIGNER TEAM:

NAAJID

ASIF

FAYYAH

NILCOFAR

SCALE: AS GIVEN

DRIVING TITLE: AS GIVEN

DATE: 02/01/2021


REVISION NO.: 00

FILE NAME:

LUCKYLAST INTERIOR PROJECT  
PROJECT LUCKYLAST PROJECT'S  
2021/01/02/0000

WARNING:

This drawing is the property of MACO DESIGNS. It is to be used only for the project and location specified. It is not to be used for any other project or location without the written consent of MACO DESIGNS. The drawing is to be used as a guide only. It is not to be used as a contract. The drawing is to be used as a guide only. It is not to be used as a contract. The drawing is to be used as a guide only. It is not to be used as a contract.


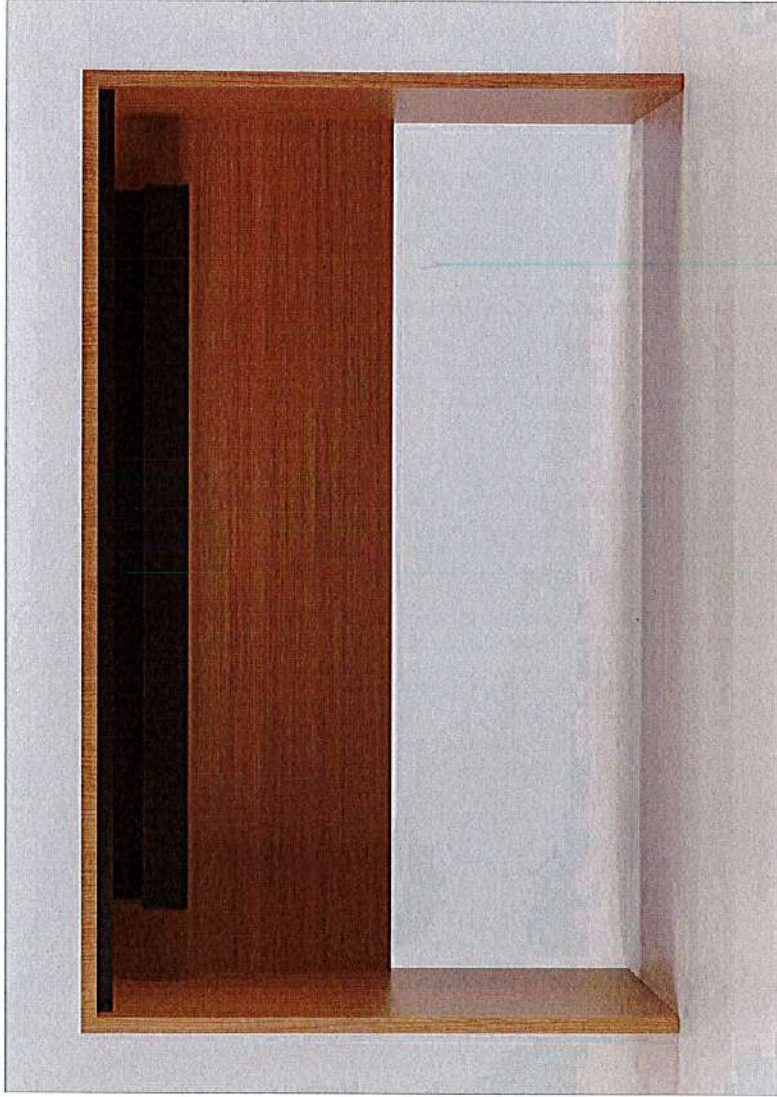


1.03 OFFICE DESK - 1  
SCALE 1:20

ID22


**NOTE**

- CL = CEILING LINE
- DCL = DROP CEILING LINE
- FFL = FLOOR FINISH LINE
- RFFL = RAISED FLOOR LINE

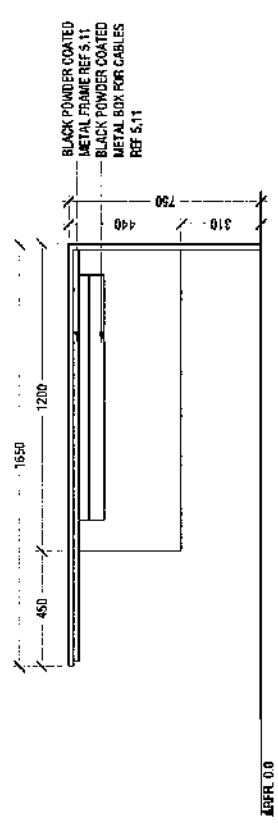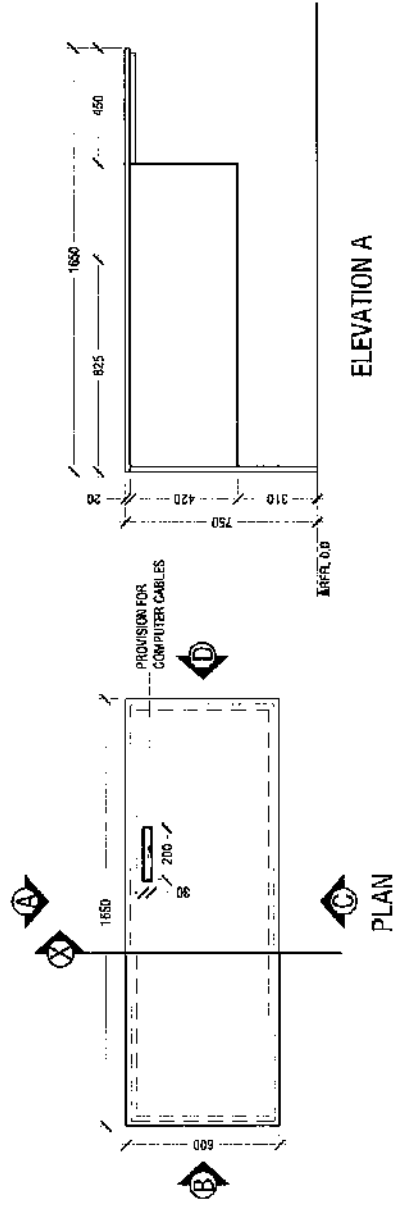


**ELEVATION A**


**ELEVATION C**

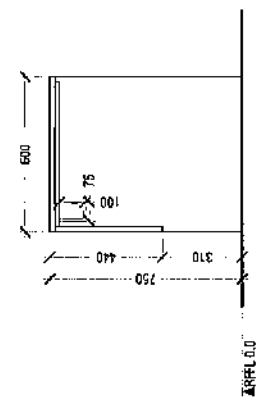

**ELEVATION B**

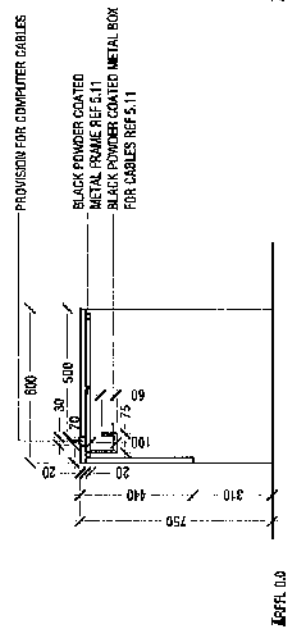

**SECTION X**

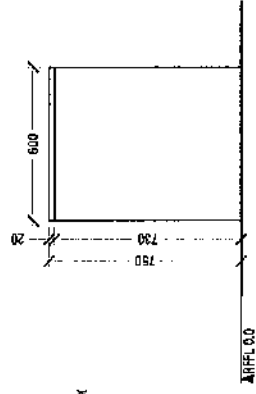

**ELEVATION D**

**AMCO**  
DESIGNS

Contact: 7889966, 7691671  
Email: info@amco.dubai

CLIENT:  
JAUFAR RASHEED

PROJECT:  
LUCKYLAST

AA.LUKULHAS

INTERIOR DESIGNER/TEAM

NAJAD

ASIF

ALIYAH

NILOOFAR

SCALE: AS GIVEN

DRIVING TITLE : AS GIVEN

DATE: 02/07/2017

REVISION NO: 01

FILE NAME:  
AMCO\PROJECTS\LUCKYLAST\LUCKYLAST.dwg

DATE PLOTTED: 02/07/2017 10:58:11 AM

PLANNER: AMCO

SCALE: AS GIVEN

DATE: 02/07/2017 10:58:11 AM

PLANNER: AMCO

SCALE: AS GIVEN

DATE: 02/07/2017 10:58:11 AM

PLANNER: AMCO

**1.04** OFFICE DESK - 2  
SCALE 1:20

• TABLE TOP AND LEGS FINISHED IN PINE WOOD LAMINATE REF 5.08


**ID23**






NOTE


- CL = CEILING LINE
- DCL = DROP CEILING LINE
- FFL = FLOOR FINISH LINE
- RFFL = RAISED FLOOR LINE

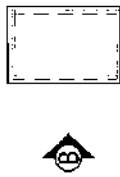


PLAN

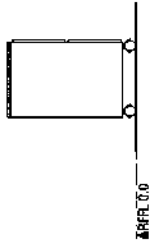

ELEVATION B

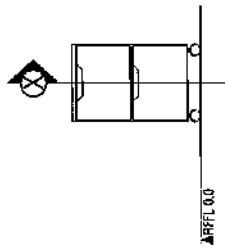

ELEVATION A

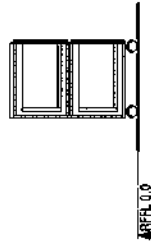

SECTION X

**MACO**  
DESIGNS  
Contact: 79889866, 76916771  
Email: info@maco.my

CLIENT:  
**JAUFAR RASHEED**

PROJECT:  
**LUCKYLAST**  
**AAJUKULHAS**

INTERIOR DESIGNER TEAM  
**NAAJID**  
**ASIF**  
**FATYAH**  
**NILDOFAR**

SCALE: AS SHOWN  
DRAWING TITLE: AS GIVEN  
DATE: 02/04/2021

REVISION NO.: 06  
FILE NAME:  
S:\01-2021\02\04\01\LUCKYLAST\PROJECTS\PROJECTS\AS SHOWN

DISCLAIMER:  
This drawing is for information only and is not to be used for construction without the approval of the designer. The designer shall not be held responsible for any errors or omissions in this drawing. The client shall be responsible for the accuracy of the information provided to the designer.



1.05 FILE CABINET  
SCALE 1:20

- TOP & BASE FINISHED IN MATTE WHITE LAMINATE REF 5.09
- CARCASS & DRAWERS FINISHED IN WHITE LAMINATE 5.09

ID25

**NOTE**

- CL = CEILING LINE
- DCL = DROP CEILING LINE
- FFL = FLOOR FINISH LINE
- RFFL = RAISED FLOOR LINE

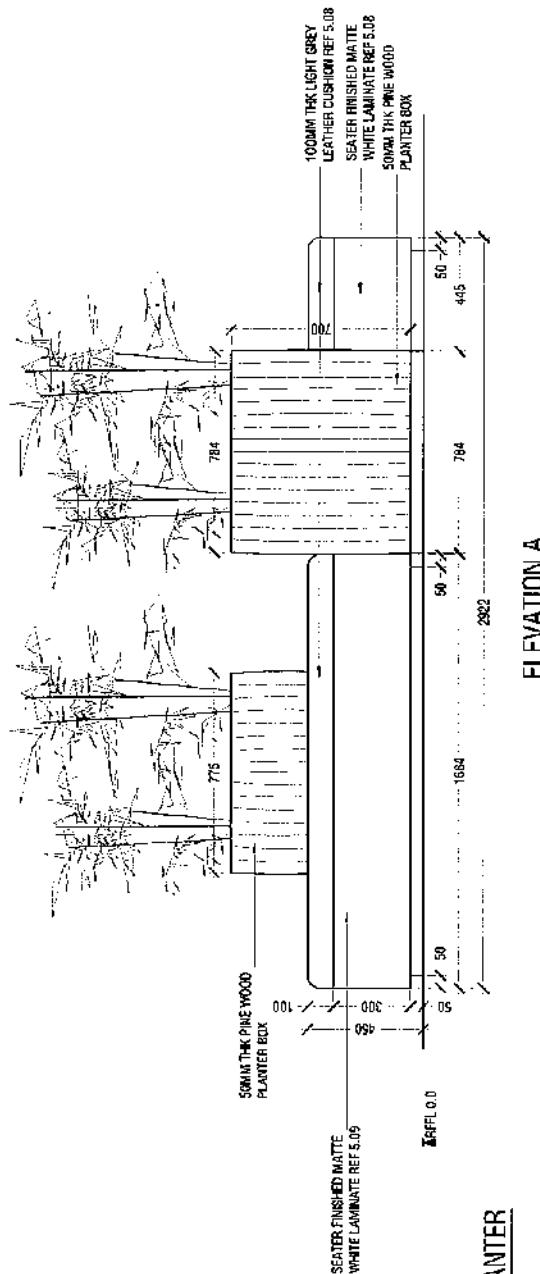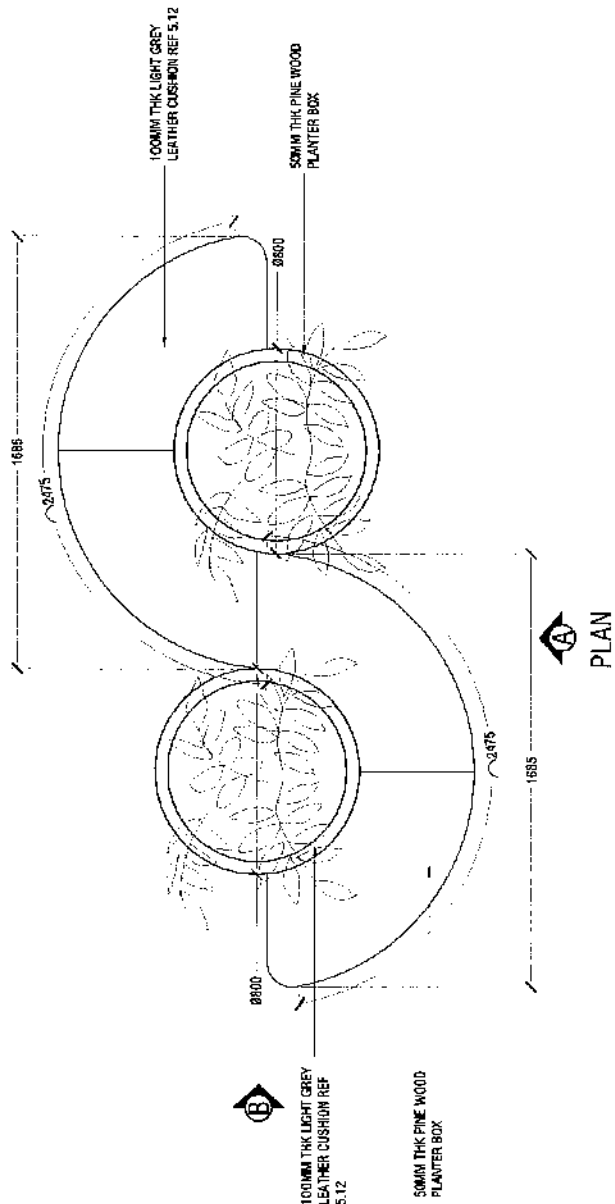

1.06 SOFA WITH PLANTER  
SCALE 1:20

**MACO**  
DESIGNS  
Contact: 9888666, 7691671  
Email: info@maco.com.my

CLIENT:  
**JAUFAR RASHEED**

PROJECT:  
**LUCKYLAST**

AA, LUKULHAS

INTERIOR DESIGNER TEAM  
NAAJID  
ASIF  
FRYYAH  
NILDOFAR


SCALE: AS SHOWN  
DRAWING TITLE : AS SHOWN  
DATE: 02/21/2019  
REVISION NO.: 00  
FILE NAME:  
PROJECT NO.:  
PROJECT NO.:

WARNING:  
THIS DRAWING IS THE PROPERTY OF MACO DESIGNS. IT IS TO BE USED ONLY FOR THE PROJECT AND LOCATION SPECIFICALLY MENTIONED HEREIN. ANY REUSE OR MODIFICATION OF THIS DRAWING WITHOUT THE WRITTEN PERMISSION OF MACO DESIGNS IS STRICTLY PROHIBITED.

**ID26**

NOTE

- CL = CEILING LINE
- DCL = DROP CEILING LINE
- FFL = FLOOR FINISH LINE
- RFFL = RAISED FLOOR LINE

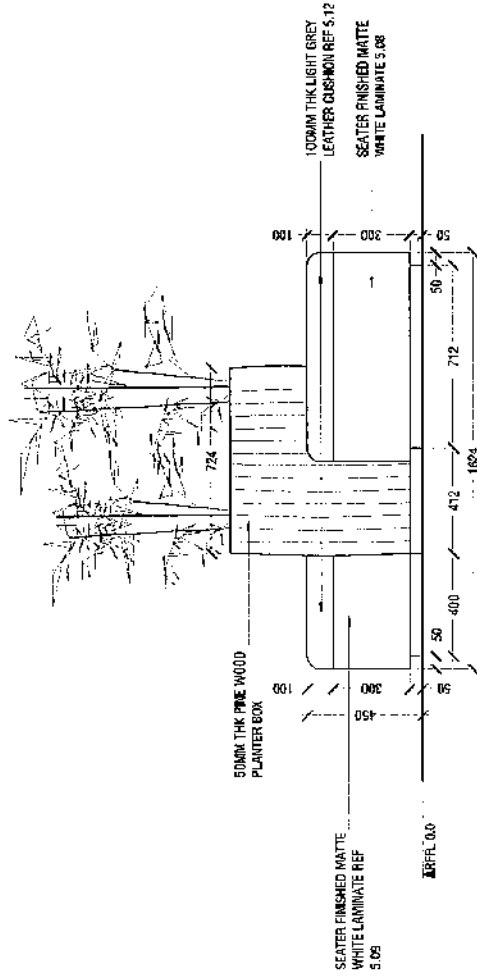

ELEVATION B

**MACO**  
DESIGNS

Contact: 76829665, 76891671

Email: info@maco.id

CLIENT:

JALUAR PASHIED

PROJECT:

LUCKYLAST

AAJUKULHAS

INTERIOR DESIGN TEAM

MAAJIID

RSIF

RYAN

NILDOFFAR

SCALE: AS GIVEN

DRAWING TITLE : AS GIVEN

DATE: 02/01/2021

PROJECT NO.: 00

FILE NAME:


D:\PROJECTS\2020\1824\LUCKYLAST\LUCKYLAST\LUCKYLAST.dwg

DATE PLOTTED: 02/01/2021 10:00:00 AM

PLANNER: M. A. A. A.

WARNING:

This drawing is the property of MACO DESIGNS and is not to be reproduced, stored in a retrieval system, or transmitted in any form or by any means, electronic, mechanical, photocopying, recording, or by any information storage and retrieval system, without the prior written permission of MACO DESIGNS.

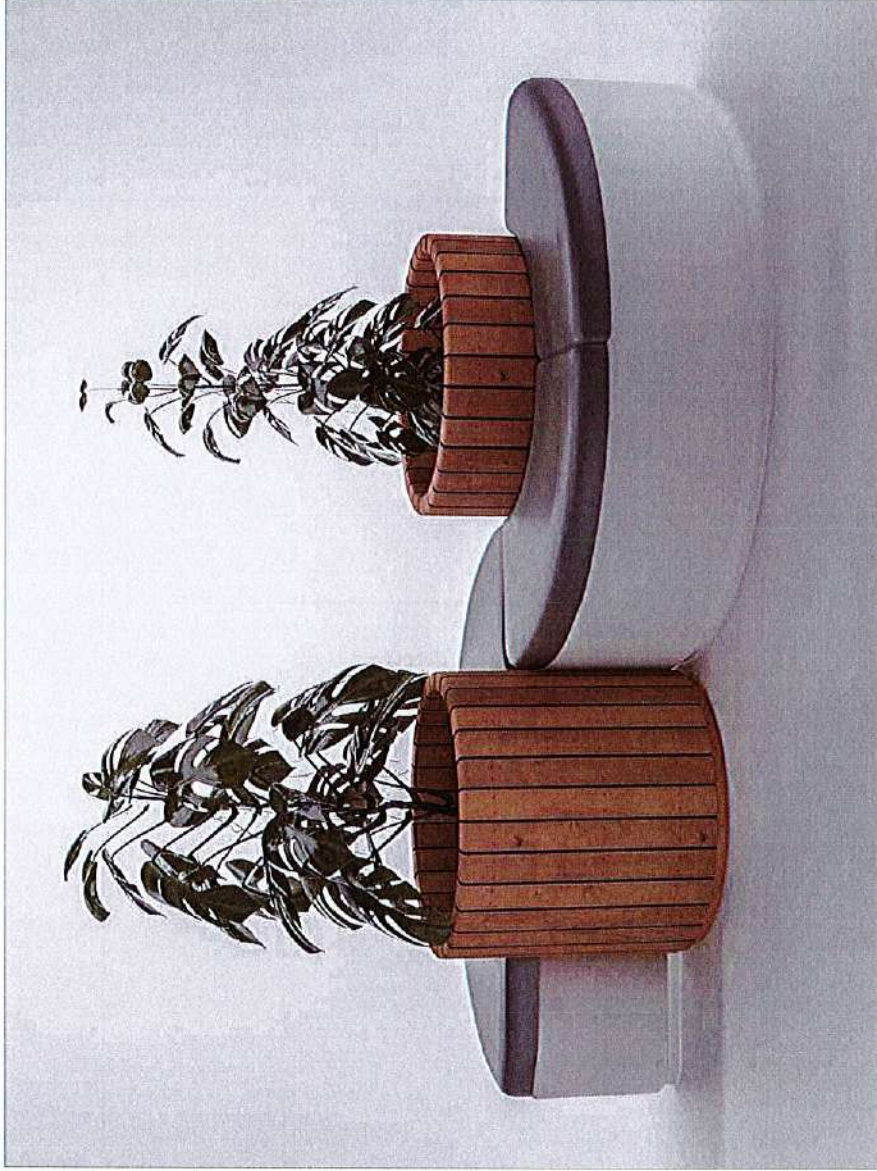

**MMCO**  
DESIGNS  
Contact: 7889966, 7691671  
Email: info@mmco.my

CLIENT:  
JAUFAR RASHEED

PROJECT:  
LUCKYLAST

AA.UKULHAS

INTERIOR DESIGNER TEAM  
NAAJID  
ASIF  
FAYYAH  
NILOOFAR

SCALE: AS SHOWN

DRAWING TITLE: AS GIVEN

DATE: 02/07/2021


REVISION NO.: 00

FILE NAME:  
PROJECT: INTERIOR PRODUCTS  
REF: LUCKYLAST (001).DWG

WARNING:  
This drawing is the property of MMCO. It is to be used only for the project and location specified. It is not to be reproduced, stored in a retrieval system, or transmitted in any form or by any means, electronic, mechanical, photocopying, recording, or by any information storage and retrieval system, without the prior written permission of MMCO. The user of this drawing is to be held responsible for any errors or omissions. The user of this drawing is to be held responsible for any errors or omissions. The user of this drawing is to be held responsible for any errors or omissions.

1.06 SOFA WITH PLANTER  
SCALE 1:20


ID28

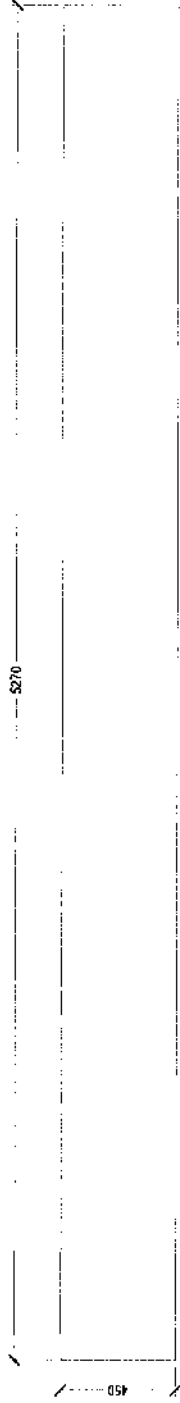

NOTE

- CL = CEILING LINE
- DCL = DROP CEILING LINE
- FFL = FLOOR FINISH LINE
- RFFL = RAISED FLOOR LINE

**A**  
PLAN

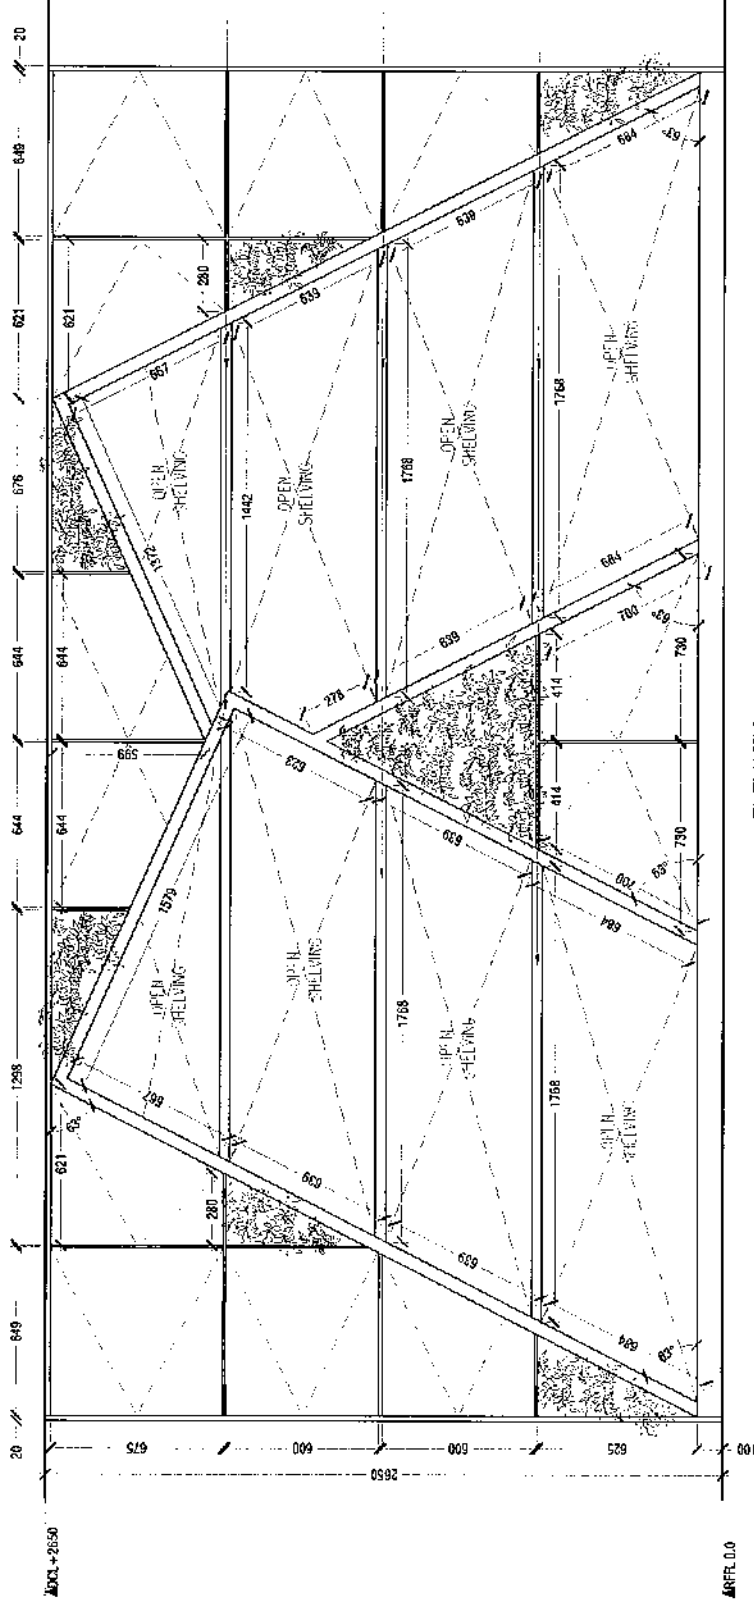

ELEVATION A

- TOP & BASE FINISHED IN MATTE WHITE LAMINATE REF 5.09
- HINGE DOORS FINISHED IN MATTE WHITE LAMINATE REF 5.09
- DIAGONAL FRAMES FINISHED IN PINE WOOD LAMINATE REF 5.08
- CARCASS AND SHELVES FINISHED MATTE WHITE LAMINATE UNLESS SPECIFIED OTHERWISE REF 5.09
- PLASTIC FOLIAGE TO BE USED IN ALL INDICATED SURFACES

1.07 CABINET - 1  
SCALE 1:20

**AMCO**  
DESIGNS  
Contact: 79893866, 7691671  
Email: info@amco.nv

CLIENT: JAUFAR RASHEED  
PROJECT: LUCKYLAST  
AAJIKULHAS

INTERIOR DESIGNER TEAM  
NAAJID  
ASIF  
FAYYAH  
MULOOFAR

SCALE: AS GIVEN  
DRAWING TITLE: AS GIVEN  
DATE: 02/04/2023  
REVISION NO: 09  
FILE NAME  
WORKING FOLDER: AMCO  
PROJECTS/INTERIOR PROJECTS/AAJIKULHAS/

WARNING: THIS DRAWING IS THE PROPERTY OF AMCO DESIGNS. IT IS TO BE USED ONLY FOR THE PROJECT AND SITE SPECIFICALLY MENTIONED. IT IS NOT TO BE REPRODUCED, COPIED, OR TRANSMITTED IN ANY FORM OR BY ANY MEANS, ELECTRONIC OR MECHANICAL, INCLUDING PHOTOCOPYING, RECORDING, OR BY ANY INFORMATION STORAGE AND RETRIEVAL SYSTEM, WITHOUT THE WRITTEN PERMISSION OF AMCO DESIGNS.

**ID29**

**NOTE**

- CL = CEILING LINE
- DCL = DROP CEILING LINE
- FFL = FLOOR FINISH LINE
- RFFL = RAISED FLOOR LINE

**MACO**  
DESIGNS  
CONTACT: 7985966, 7591671  
Email: info@maco.gov


DESIGNER:  
**JAUFAR RASHEED**  
PROJECT:  
**LUCKYLAST**  
ARCHITECT:  
**AAJUKULHAS**

INTERIOR DESIGNER TEAM:  
**NNAJID**  
**ASIF**  
**FAYYAH**  
**NILCOFAR**

SCALE: AS GIVEN  
DRAWING TITLE: AS GIVEN  
DATE: 02/20/2023  
REVISION NO.: 00  
FILE NAME:  
PROJECT LOCATION: MALACCA  
PROJECT NUMBER: P00000000000000000000  
PROJECT DATE: 02/20/2023

**WARNING:**  
THIS DRAWING IS THE PROPERTY OF MACO DESIGNS. IT IS TO BE USED ONLY FOR THE PROJECT AND SITE SPECIFICALLY IDENTIFIED HEREIN. IT IS NOT TO BE REPRODUCED, COPIED, OR TRANSMITTED IN ANY FORM OR BY ANY MEANS, ELECTRONIC OR MECHANICAL, INCLUDING PHOTOCOPYING, RECORDING, OR BY ANY INFORMATION STORAGE AND RETRIEVAL SYSTEM, WITHOUT THE WRITTEN PERMISSION OF MACO DESIGNS.

**ID30**

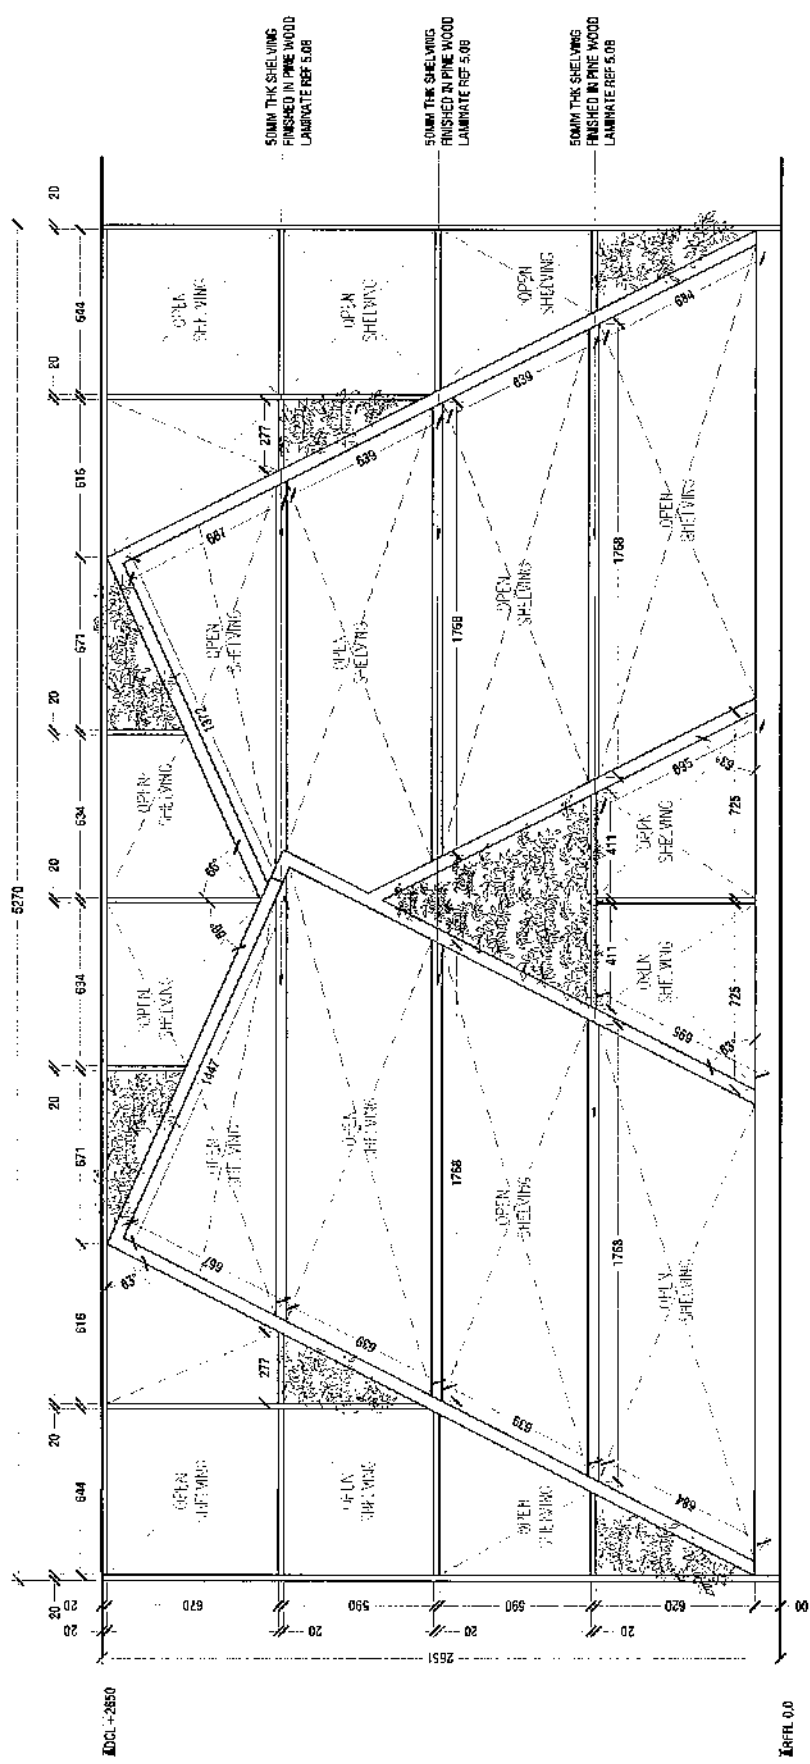


OPEN ELEVATION A

- TOP & BASE FINISHED IN MATTE WHITE LAMINATE REF 5.09
- HINGE DOORS FINISHED IN MATTE WHITE LAMINATE REF 5.09
- DIAGONAL FRAMES FINISHED IN PINE WOOD LAMINATE REF 5.08
- CARCASS AND SHELVES FINISHED MATTE WHITE LAMINATE UNLESS SPECIFIED OTHERWISE REF 5.09
- PLASTIC FOLIAGE TO BE USED IN ALL INDICATED SURFACES

**1.07** CABINET - 1  
SCALE 1:20

NOTE

- CL = CEILING LINE
- DCL = DROP CEILING LINE
- FFL = FLOOR FINISH LINE
- RFFL = RAISED FLOOR LINE

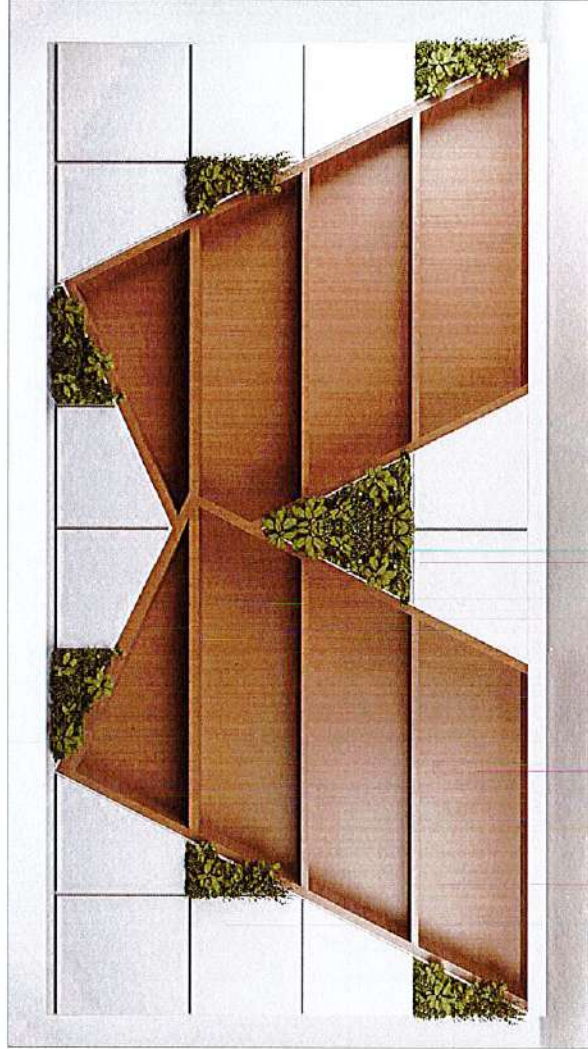

- TOP & BASE FINISHED IN MATTE WHITE LAMINATE REF 5.09
- HINGE DOORS FINISHED IN MATTE WHITE LAMINATE REF 5.09
- DIAGONAL FRAMES FINISHED IN PINE WOOD LAMINATE REF 5.08
- CARCASS AND SHELVES FINISHED MATTE WHITE LAMINATE UNLESS SPECIFIED OTHERWISE REF 5.09
- PLASTIC FOLIAGE TO BE USED IN ALL INDICATED SURFACES

**MACO**  
DESIGNS

Contact: 9989666, 7691671  
Email: info@maco.my

CUBIT:

PROJECT:

LUCKYLAST

AA.LUKULHAS

INTERIOR DESIGNER TANAI

NAAJID

ASIF

FAYYAH

NILLOOFAR

SCALE: AS GIVEN

DRAWING TITLE : AS GIVEN

DATE: 02/01/2021

REVISION NO.: 00

FILE NAME:

PROJECT LOCATION: TANAI  
NOVA CITY 80110 (KUALA LUMPUR)  
REVISION NO.: 00

WARNING:

THIS DRAWING IS THE PROPERTY OF MACO DESIGNS. IT IS TO BE USED ONLY FOR THE PROJECT AND SITE SPECIFICALLY MENTIONED. IT IS NOT TO BE REPRODUCED, COPIED, OR TRANSMITTED IN ANY FORM OR BY ANY MEANS, ELECTRONIC OR MECHANICAL, INCLUDING PHOTOCOPYING, RECORDING, OR BY ANY INFORMATION STORAGE AND RETRIEVAL SYSTEM. WITHOUT THE WRITTEN PERMISSION OF MACO DESIGNS. THE USER AGREES TO HOLD MACO DESIGNS HARMLESS FROM ALL LIABILITY ARISING FROM THE USE OF THIS DRAWING. THE USER AGREES TO HOLD MACO DESIGNS HARMLESS FROM ALL LIABILITY ARISING FROM THE USE OF THIS DRAWING.

1.07 CABINET - 1  
SCALE 1:20

ID31





**AMACO**  
DESIGNS  
Contact: 7888986, 7691671  
Email: info@amaco.my

CLIENT:  
JAUFAR RASHEED

PROJECT:  
LUCKYLAST  
AAJUKULHAS

INTERIOR DESIGNER TEAM  
NAAJID  
ASIF  
FAYYAH  
NILOOPAR

SCALE: AS GIVEN

DRAWING TITLE: AS GIVEN

DATE: 02/04/2021

REVISION NO.: 00

FILE NAME:  
D:\AMACO\DRAWING\AMACO  
PROJECTS\LUCKYLAST\LUCKYLAST  
ID33.DWG

**WARNING:**  
THIS DRAWING IS THE PROPERTY OF AMACO  
DESIGNS. IT IS TO BE USED ONLY FOR THE  
PROJECT AND SITE SPECIFICALLY MENTIONED IN THIS  
DRAWING. ANY REUSE, REPRODUCTION, OR  
ALTERATION OF THIS DRAWING WITHOUT THE  
WRITTEN PERMISSION OF AMACO DESIGNS  
IS STRICTLY PROHIBITED. AMACO DESIGNS  
ACCEPTS NO LIABILITY FOR ANY DAMAGE OR  
LOSS OF DATA ARISING FROM THE USE OF  
THIS DRAWING.







1.08 PLANTER  
SCALE 1:20

ID33

**NOTE**

- CL = CEILING LINE
- DCL = DROP CEILING LINE
- FFL = FLOOR FINISH LINE
- RFFL = RAISED FLOOR LINE

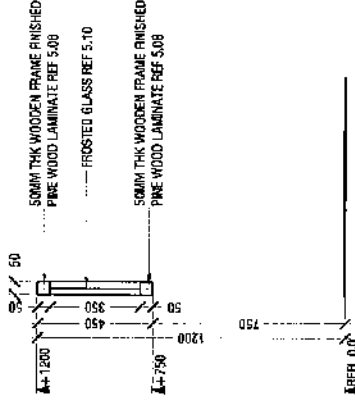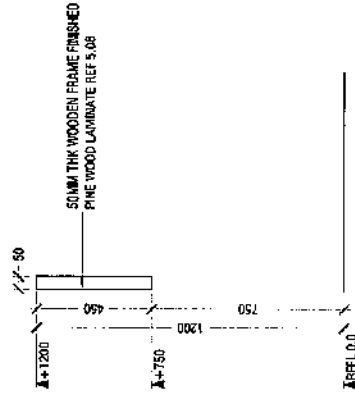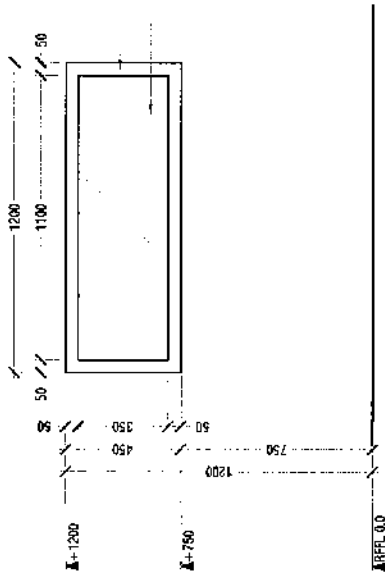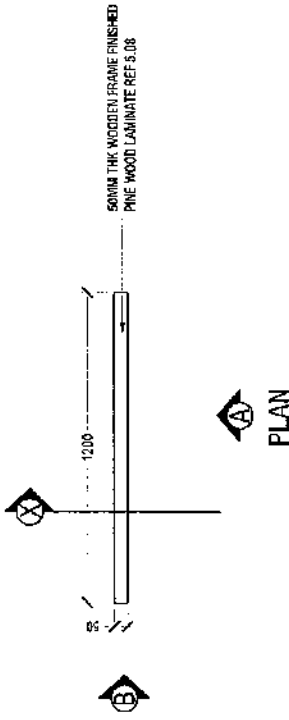

**MACO**  
O F F I C E S  
Contact: 7889986, 7691871  
Email: info@maco.com.my

PROJECT:  
**JAUFAR RASHEED**

PROJECT:  
**LUCKYLAST**

AA, UKULHAS

INTERIOR DESIGNER TEAM  
NAAJID  
ASIF  
FAYYAH  
NILCOOFAR

SCALE AS GIVEN

DRAWING TITLE: AS GIVEN

DATE: 02/04/2021

REVISION NO.: 00

FILE NAME:  
D:\PROJECTS\2021\LUCKYLAST\PROJECTS\LUCKYLAST\LUCKYLAST.dwg

**WARNING:**  
This drawing is the property of MACO. It is not to be used, copied, or reproduced in any form without the written permission of MACO. The user of this drawing is responsible for its use and for any errors or omissions. The user of this drawing is also responsible for obtaining all necessary permits and approvals from the relevant authorities.

1.09 TABLE PARTITION  
SCALE 1:20

**ID34**

**MACO**  
DESIGNS  
Contact: 7989966, 7691671  
Email: info@maco.my

CLIENT:  
JAUFAR RASHEED

PROJECT:  
LUCKYLAST

AAUKULHAS

INTERIOR DESIGNER TEAM  
NAAJID  
ASIF  
FAYYAH  
NILOOFAR

SCALE AS GIVEN


DRAWING TITLE : AS GIVEN

DATE 02/07/2021

REVISION NO. 00

FILE NAME  
UNLAKED PROJECTS - MACO  
PROJECTS INTERIOR PROJECTS  
2021/07/02/0000000000

**WARNING:**  
This drawing is the property of MACO DESIGNS. It is to be used only for the project and location specified. It is not to be reproduced, copied, or distributed without the written consent of MACO DESIGNS. The user of this drawing is to ensure that all dimensions and materials are as specified. The user is to ensure that all work is done in accordance with the relevant building codes and regulations. The user is to ensure that all work is done in accordance with the relevant building codes and regulations. The user is to ensure that all work is done in accordance with the relevant building codes and regulations.

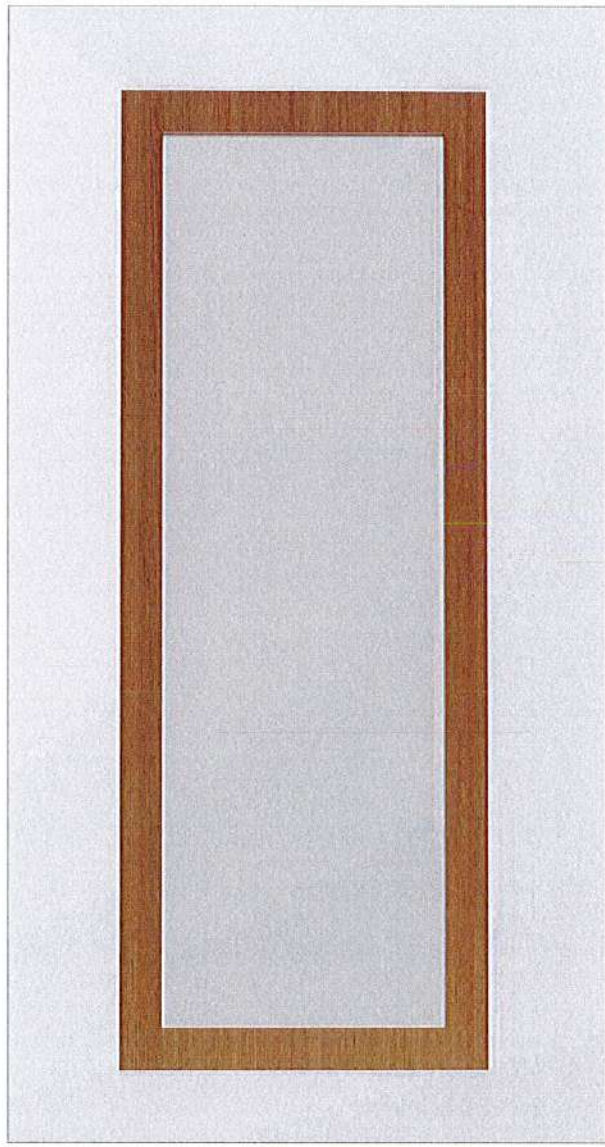

1.09 TABLE PARTITION  
SCALE 1:20

ID35

**NOTE**

- CL = CEILING LINE
- DCL = DROP CEILING LINE
- FFL = FLOOR FINISH LINE
- RFFL = RAISED FLOOR LINE



Contact: 7988866, 781871  
Email: info@mamo.my

CLIENT:  
JAUFAR RASHEED

PROJECT:  
LUCKYLAST

AAJUKULHAS

INTERIOR DESIGNER TEAM  
MAAJID  
ASIF  
FAYYAH  
NILOOPAR

SCALE: AS SHOWN

DRAWING TITLE: AS SHOWN



DATE: 02/01/2021

REVISION NO. 00


FILE NAME:  
1.10 STORAGE - 2

PROJECT LOCATION: MAMO  
PROJECT TYPE: STORAGE PROJECTS  
PROJECT NO: 20210101

**WARNING:**  
THIS DRAWING IS THE PROPERTY OF MAMO DESIGN. IT IS TO BE USED ONLY FOR THE PROJECT AND SITE SPECIFICALLY MENTIONED HEREIN. IT IS NOT TO BE REPRODUCED, COPIED, OR TRANSMITTED IN ANY FORM OR BY ANY MEANS, ELECTRONIC OR MECHANICAL, INCLUDING PHOTOCOPYING, RECORDING, OR BY ANY INFORMATION STORAGE AND RETRIEVAL SYSTEM, WITHOUT THE WRITTEN PERMISSION OF MAMO DESIGN.

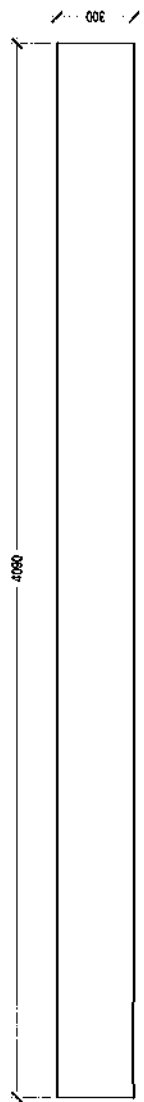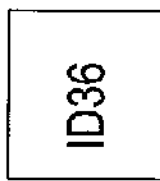

**PLAN**

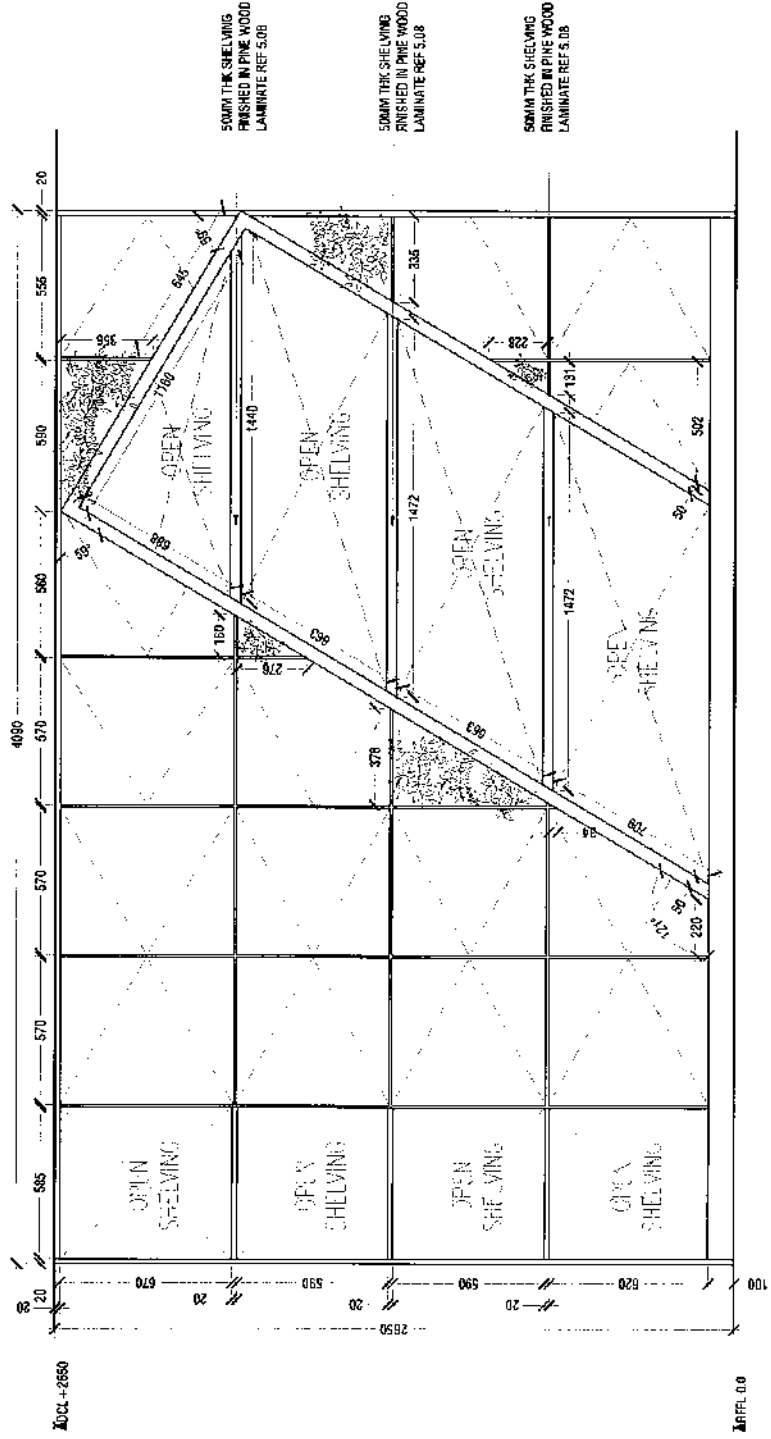

**ELEVATION A**

- TOP & BASE FINISHED IN MATTE WHITE LAMINATE REF 5.09
- HINGE DOORS FINISHED IN MATTE WHITE LAMINATE REF 5.09
- DIAGONAL FRAMES FINISHED IN PINE WOOD LAMINATE REF 5.08
- CARCASS AND SHELVES FINISHED MATTE WHITE LAMINATE UNLESS SPECIFIED OTHERWISE REF 5.09
- PLASTIC FOLIAGE TO BE USED IN ALL INDICATED SURFACES

**1.10 STORAGE - 2**  
SCALE 1:20

NOTE

- CL = CEILING LINE
- DCL = DROP CEILING LINE
- FFL = FLOOR FINISH LINE
- RFFL = RAISED FLOOR LINE

**MACO**

DESIGNS

Contact: 7889966, 768-1871

Email: info@maco.my

CLIENT:

JAUFAR RASHEED

PROJECT:

LUCKYLAST

AA, UKULHAS

INTERIOR DESIGNER TEAM

NAAZID

ASIF

FAYYAZ

NILOOFAR

SCALE: AS SHOWN

DRAWING TITLE: AS GIVEN

DATE: 03/28/2021

REVISION NO.: 01

FILE NAME:


\\MACO-RT\DRAWINGS\PROJECTS

2021\03\LUCKYLAST\ID37

WARNING:

THIS DRAWING IS THE PROPERTY OF MACO DESIGNS. IT IS TO BE USED ONLY FOR THE PROJECT AND SITE SPECIFICALLY MENTIONED HEREIN. IT IS NOT TO BE REPRODUCED, COPIED, OR TRANSMITTED IN ANY FORM OR BY ANY MEANS, ELECTRONIC OR MECHANICAL, WITHOUT THE WRITTEN PERMISSION OF MACO DESIGNS.

**ID37**

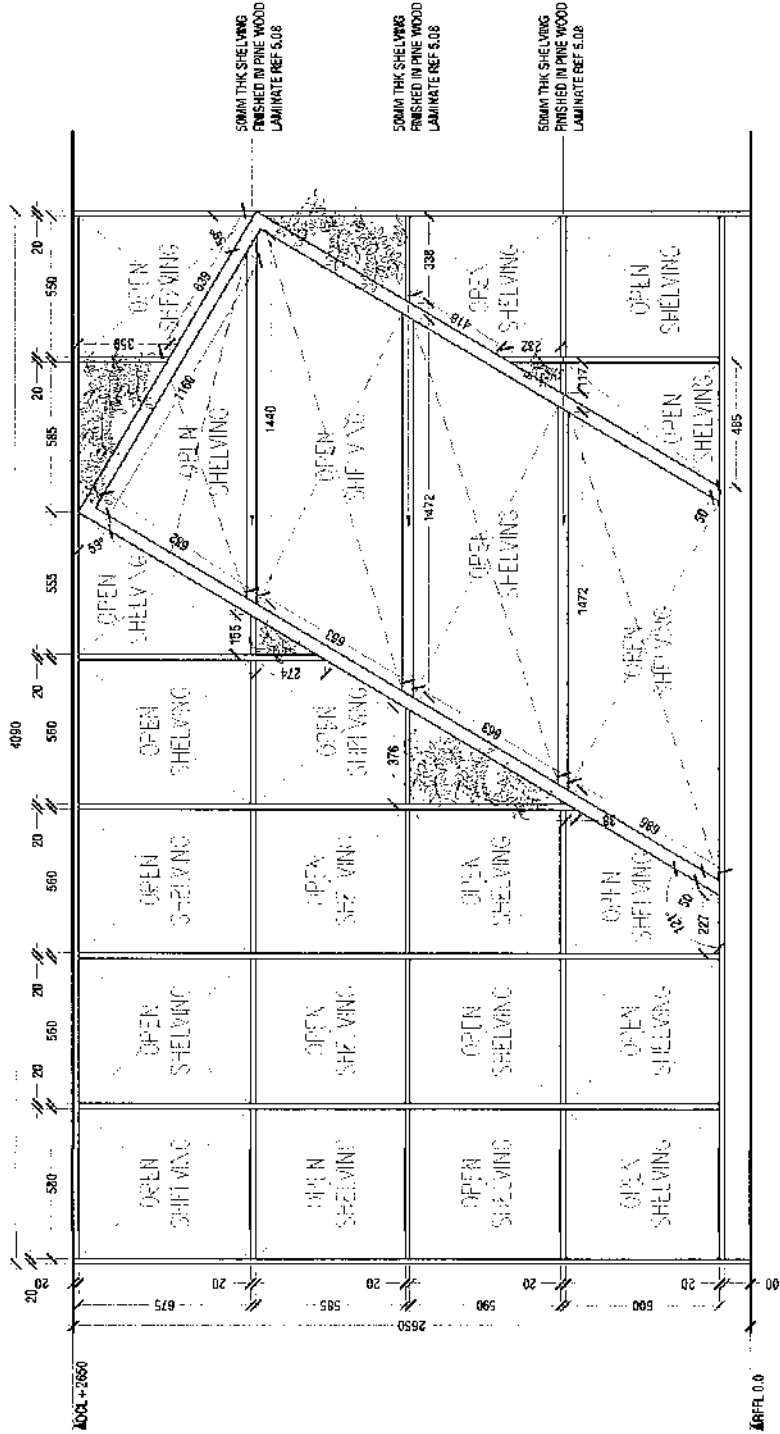


OPEN ELEVATION A

- TOP & BASE FINISHED IN MATTE WHITE LAMINATE REF 5.09
- HINGE DOORS FINISHED IN MATTE WHITE LAMINATE REF 5.09
- DIAGONAL FRAMES FINISHED IN PINE WOOD LAMINATE REF 5.08
- CARCASS AND SHELVES FINISHED MATTE WHITE LAMINATE UNLESS SPECIFIED OTHERWISE REF 5.09
- PLASTIC FOLIAGE TO BE USED IN ALL INDICATED SURFACES

**1.10** STORAGE - 2  
SCALE 1:20


NOTE

- CL = CEILING LINE
- DCL = DROP CEILING LINE
- FFL = FLOOR FINISH LINE
- RFFL = RAISED FLOOR LINE

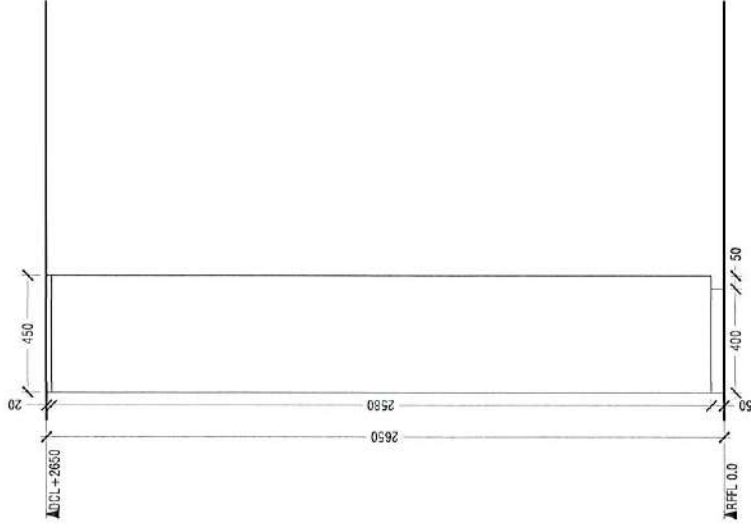

ELEVATION B

1.10 STORAGE - 2  
SCALE 1:20

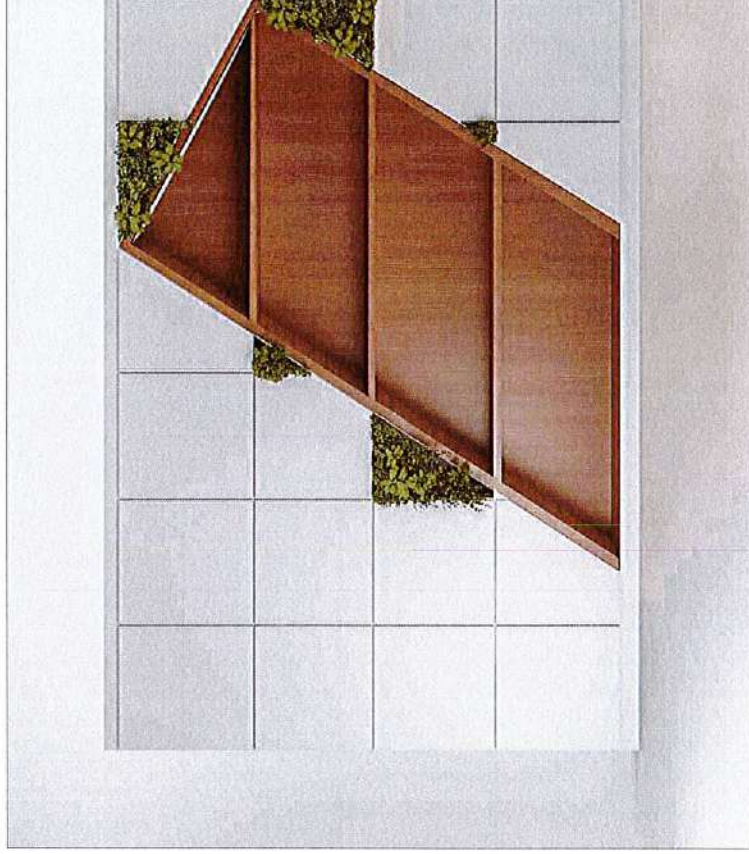

- TOP & BASE FINISHED IN MATTE WHITE LAMINATE REF 5.09
- HINGE DOORS FINISHED IN MATTE WHITE LAMINATE REF 5.09
- DIAGONAL FRAMES FINISHED IN PINE WOOD LAMINATE REF 5.08
- CARCASS AND SHELVES FINISHED MATTE WHITE LAMINATE UNLESS SPECIFIED OTHERWISE REF 5.09
- PLASTIC FOLIAGE TO BE USED IN ALL INDICATED SURFACES

**MACO**  
DESIGNS

Contact: 79899566, 7691671  
Email: info@maco.my

CLIENT:

JALIFAR RASHEED

PROJECT:

LUCKYLAST

AAJUKULHAS

INTERIOR DESIGNER TEAM

NAAJID  
ASIF  
FAYYAH  
NILDOOFAR

SCALE: AS SHOWN

DRAWING TITLE : AS GIVEN

DATE: 02/01/2021

REVISION NO.: 00

FILE NAME:

X:\ARCHITECTURE\PROJECTS  
PROJECTS\INTERIOR PROJECTS  
LUCKYLAST\LUCKYLAST.dwg


WARNING:

This drawing shall not be used for construction or any other purpose without the written consent of MACO DESIGNS. The drawing is the property of MACO DESIGNS and shall remain the property of MACO DESIGNS. All rights reserved. No part of this drawing may be reproduced, stored in a retrieval system, or transmitted, in any form or by any means, electronic, mechanical, photocopying, recording, or by any information storage and retrieval system, without the prior written permission of MACO DESIGNS.


ID38

**NOTE**

- CL = CEILING LINE
- DCL = DROP CEILING LINE
- FFL = FLOOR FINISH LINE
- RFFL = RAISED FLOOR LINE

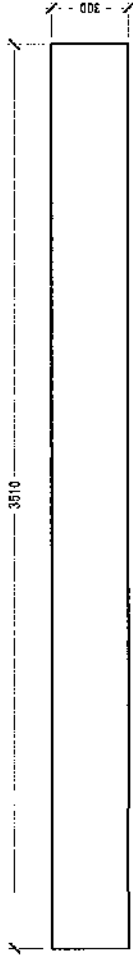

**PLAN**

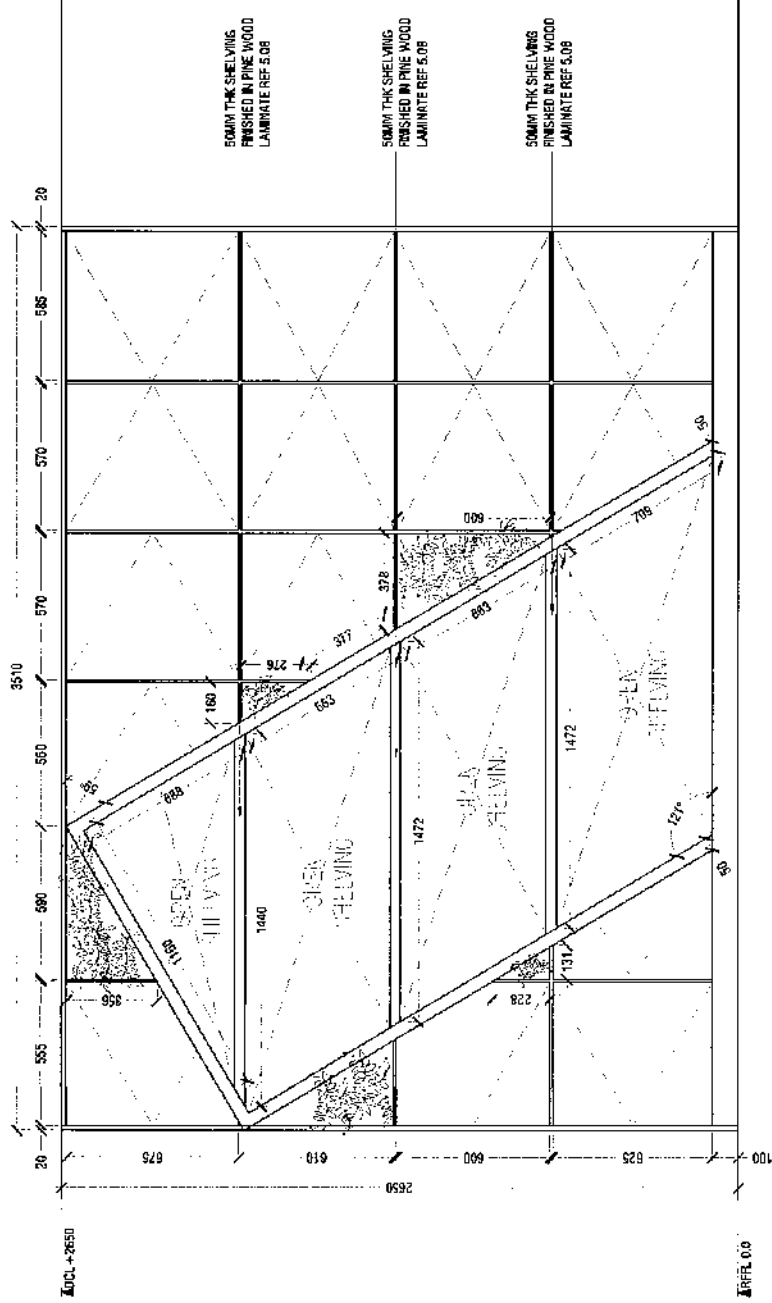

**ELEVATION A**

**AMACO**  
DESIGNS

Contact: 7989666, 7691671  
Email: info@amaco.my

CLIENT:

JAUFAR RASHEED

PROJECT:

LUCKYLAST

AAJUKUHAS

INTERIOR DESIGNER TEAM

NAAJID

ASIF

FAYYAH

NILOOFAR

SCALE: AS GIVEN

DRAWING TITLE: AS GIVEN

DATE: 02/04/2022

REVISION NO. 06

REF NAME

UNIT: MILLIMETERS (MM)

INDUSTRIAL DESIGN PRODUCTS

ARCHITECTURAL SOFTWARE

WARNING:

THIS DRAWING IS THE PROPERTY OF AMACO DESIGNS AND IS NOT TO BE REPRODUCED OR TRANSMITTED IN ANY FORM OR BY ANY MEANS, ELECTRONIC OR MECHANICAL, INCLUDING PHOTOCOPYING, RECORDING, OR BY ANY INFORMATION STORAGE AND RETRIEVAL SYSTEM, WITHOUT THE WRITTEN PERMISSION OF AMACO DESIGNS.

1.11 STORAGE - 3  
SCALE 1:20

ID39

- TOP & BASE FINISHED IN MATTE WHITE LAMINATE REF 5.09
- HINGE DOORS FINISHED IN MATTE WHITE LAMINATE REF 5.09
- DIAGONAL FRAMES FINISHED IN PINE WOOD LAMINATE REF 5.08
- CARCASS AND SHELVES FINISHED MATTE WHITE LAMINATE UNLESS SPECIFIED OTHERWISE REF 5.09
- PLASTIC FOLIAGE TO BE USED IN ALL INDICATED SURFACES



**NOTE**

- CL = CEILING LINE
- DCL = DROP CEILING LINE
- FFL = FLOOR FINISH LINE
- RFFL = RAISED FLOOR LINE

**MACO**  
DESIGNS  
Contact: 798966.7681671  
Email: info@maco.my

CLIENT  
**JAUFAR RASHEED**

PROJECT  
**LUCKYLAST**

AAJIKULHAS

INTERIOR DESIGNER TEAM  
NAAJID  
ASIF  
FAYVAH  
NILOOPAR

SCALE: AS SHOWN

DRAWING TITLE: AS GIVEN


DATE: 08/04/2021

REVISION NO. 00

FILE NAME  
D:\PROJECTS\LUCKYLAST\LUCKYLAST\INTERIOR\PROJECTS\LUCKYLAST\LUCKYLAST.DWG

**WARNING:**  
THIS DRAWING IS THE PROPERTY OF MACO DESIGNS. IT IS TO BE USED ONLY FOR THE PROJECT AND SITE SPECIFICALLY MENTIONED HEREIN. IT IS NOT TO BE REPRODUCED, COPIED, OR TRANSMITTED IN ANY FORM OR BY ANY MEANS, ELECTRONIC OR MECHANICAL, INCLUDING PHOTOCOPYING, RECORDING, OR BY ANY INFORMATION STORAGE AND RETRIEVAL SYSTEM, WITHOUT THE WRITTEN PERMISSION OF MACO DESIGNS.

**ID40**

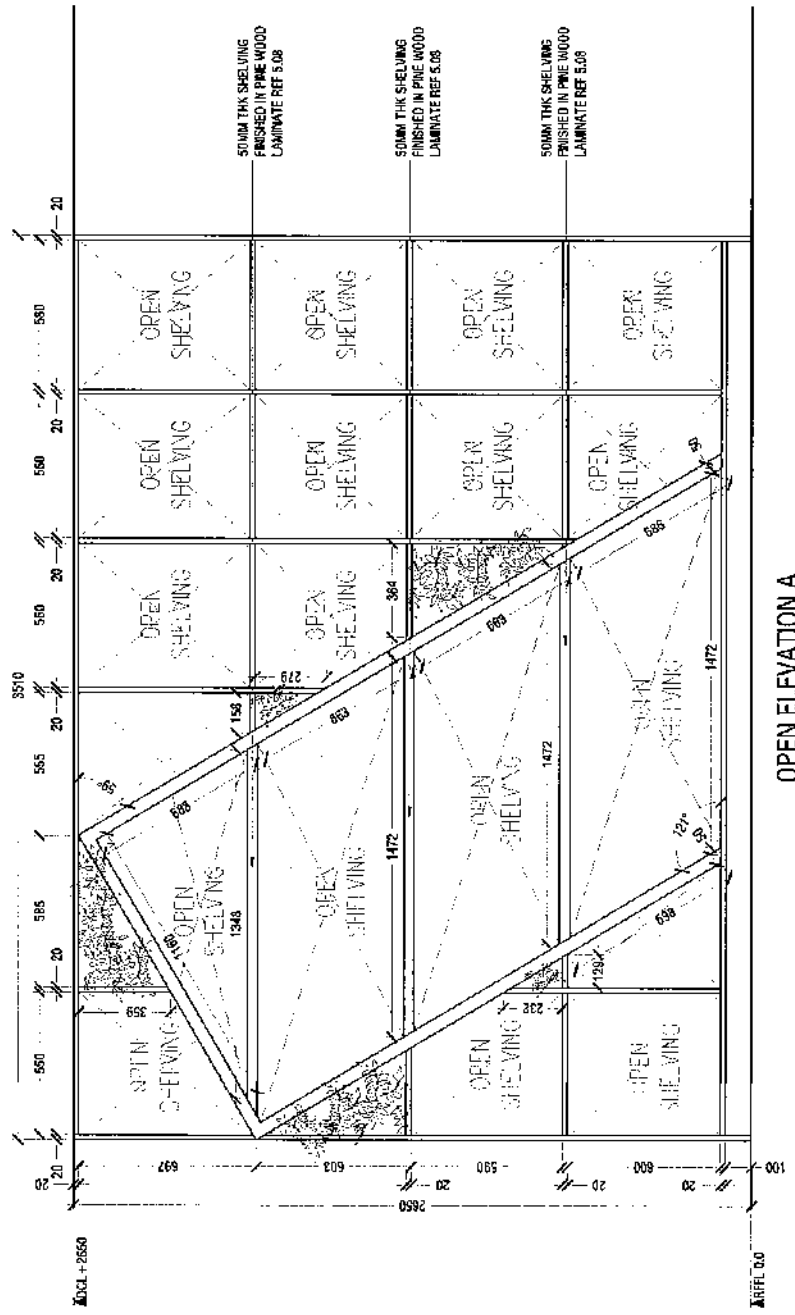

- TOP & BASE FINISHED IN MATTE WHITE LAMINATE REF 5.09
- HINGE DOORS FINISHED IN MATTE WHITE LAMINATE REF 5.09
- DIAGONAL FRAMES FINISHED IN PINE WOOD LAMINATE REF 5.08
- CARCASS AND SHELVES FINISHED MATTE WHITE LAMINATE UNLESS SPECIFIED OTHERWISE REF 5.09
- PLASTIC FOLIAGE TO BE USED IN ALL INDICATED SURFACES

**1.11** STORAGE - 3  
SCALE 1:20

NOTE

- CL = CEILING LINE
- DCL = DROP CEILING LINE
- FFL = FLOOR FINISH LINE
- RFFL = RAISED FLOOR LINE



Contact: 9889866, 7831671  
Email: info@mamo.mv

CLIENT:

JAUFAR RASHEED

PROJECT:

LUCKYLAST

AA, LUKULHAS

INTERIOR DESIGNER TEAM

NAAJID  
ASIF  
FAYYAH  
NILDOFAR

SCALE: AS GIVEN

DRAWING TITLE: AS GIVEN

DATE: 02/24/2024

REVISION NO.: 00


FILE NAME:

PROJECT: 02/24/2024 - MAMO  
PROJECT: 02/24/2024 - MAMO  
PROJECT: 02/24/2024 - MAMO


WARNING:

This drawing is for informational purposes only. It is not to be used for construction without the approval of the architect. The client is responsible for providing accurate information and for obtaining all necessary permits. The architect is not responsible for any errors or omissions in this drawing. The architect is not responsible for any construction that is not in accordance with this drawing. The architect is not responsible for any construction that is not in accordance with this drawing.

1.11 STORAGE - 3  
SCALE 1:20

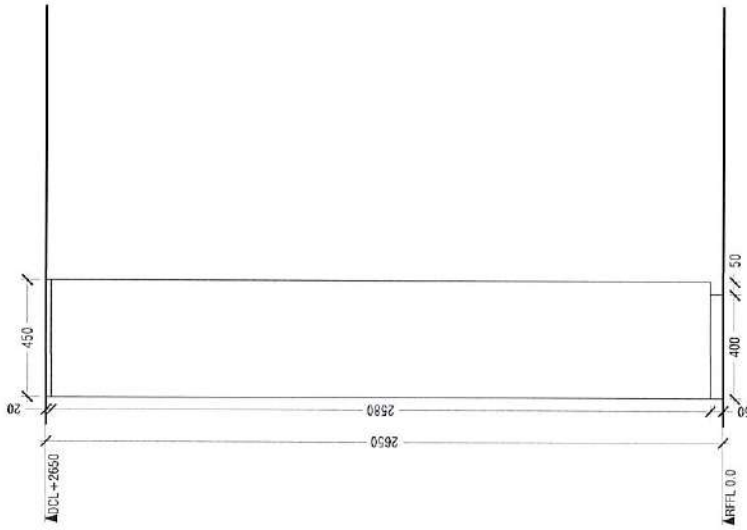

ELEVATION B

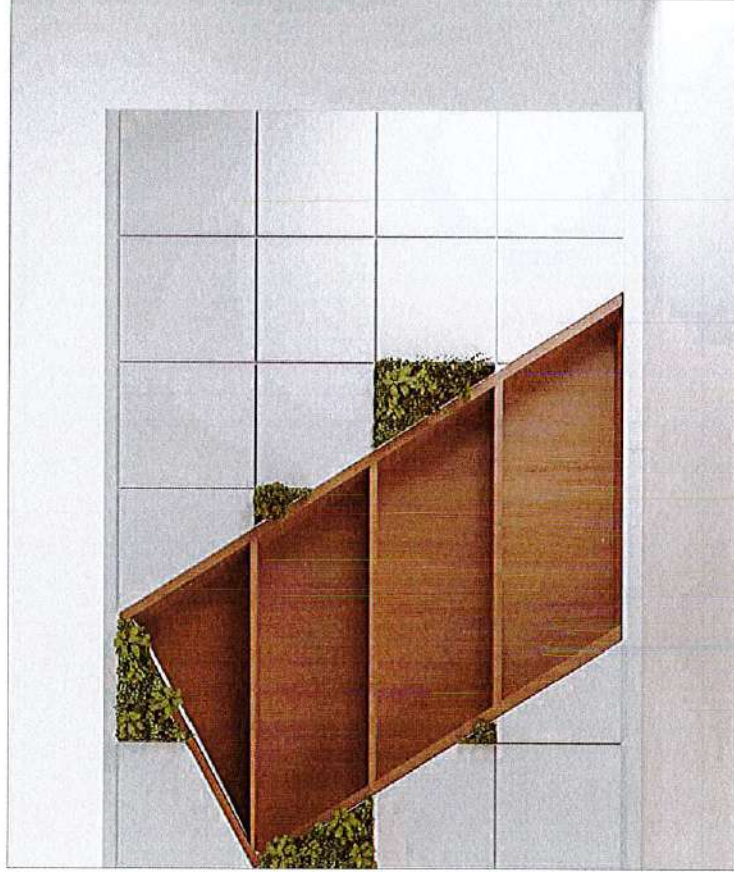

- TOP & BASE FINISHED IN MATTE WHITE LAMINATE REF 5.09
- HINGE DOORS FINISHED IN MATTE WHITE LAMINATE REF 5.09
- DIAGONAL FRAMES FINISHED IN PINE WOOD LAMINATE REF 5.08
- CARCASS AND SHELVES FINISHED MATTE WHITE LAMINATE UNLESS SPECIFIED OTHERWISE REF 5.09
- PLASTIC FOLIAGE TO BE USED IN ALL INDICATED SURFACES

ID41

**NOTE**

- CL = CEILING LINE
- DCL = DROP CEILING LINE
- FFL = FLOOR FINISH LINE
- RFFL = RAISED FLOOR LINE

**MACO**  
DESIGNS  
Contact: 7888885, 7891671  
Email: info@maco.my

CLIENT:  
JAUFAR RASHEED

PROJECT:  
**LUCKYLAST**

AA, UKUL HAS

INTERIOR DESIGNER TEAM:  
KHAJID  
ASIF  
FAYYAH  
NILDOOPAR

SCALE: AS GIVEN

DRAWING TITLE: AS GIVEN

DATE: 02/04/21

REVISION NO.: 00

FILE NAME:  
YEAR\CLIENT\PROJECT\MACO  
PROJECT\INTERIOR PROJECTS  
PROJECT\LUCKYLAST

WARNING:  
This drawing is the property of MACO DESIGNS. It is to be used only for the project and location specified. It is not to be reproduced, copied, or used for any other project without the written consent of MACO DESIGNS. All rights reserved. © 2021 MACO DESIGNS. All other rights reserved.


**1.12**  
SEATER - 1  
SCALE 1:20

**SECTION X**

**ELEVATION B**

**ELEVATION A**

**ID42**

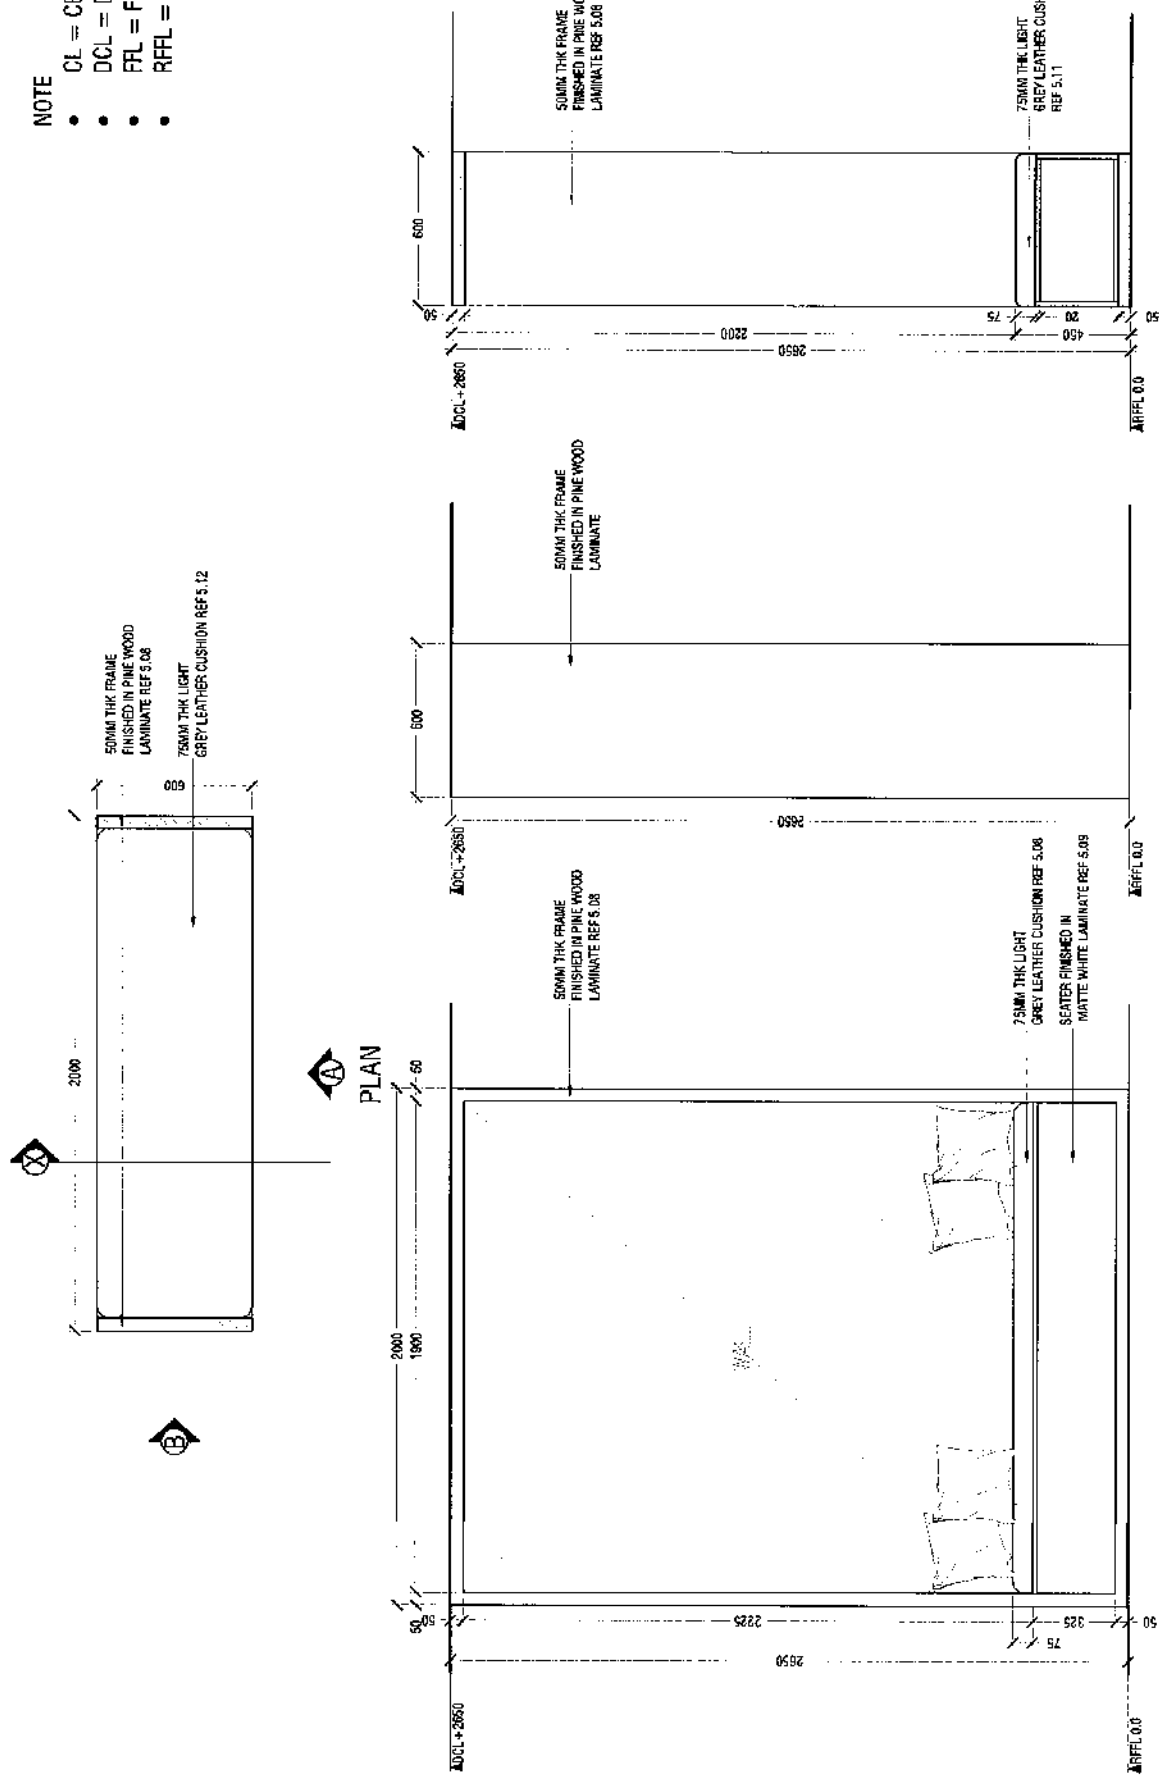

**MMCO**  
DESIGNS

Contact: 9999966, 7691671  
Email: info@mmco.my

CLIENT:

GURAIHOO COUNCIL

PROJECT:

GURAIHOO  
COUNCIL OFFICE

INTERIOR DESIGNER TEAM

SHIFAU  
NAAJID  
ASIF  
FAYYAH  
NILCOOFAR

SCALE: AS GIVEN

DRAWING TITLE : AS GIVEN

DATE: 02/10/2022


REVISION NO.: 00

FILE NAME:

PROJECTS\PROJECTS\MMCO  
PROJECTS\PROJECTS\PROJECTS

WARNING:

This drawing is the property of MMCO and is not to be reproduced, stored in a retrieval system, or transmitted in any form or by any means, electronic, mechanical, photocopying, recording, or by any information storage and retrieval system, without the prior written permission of MMCO. All rights reserved.



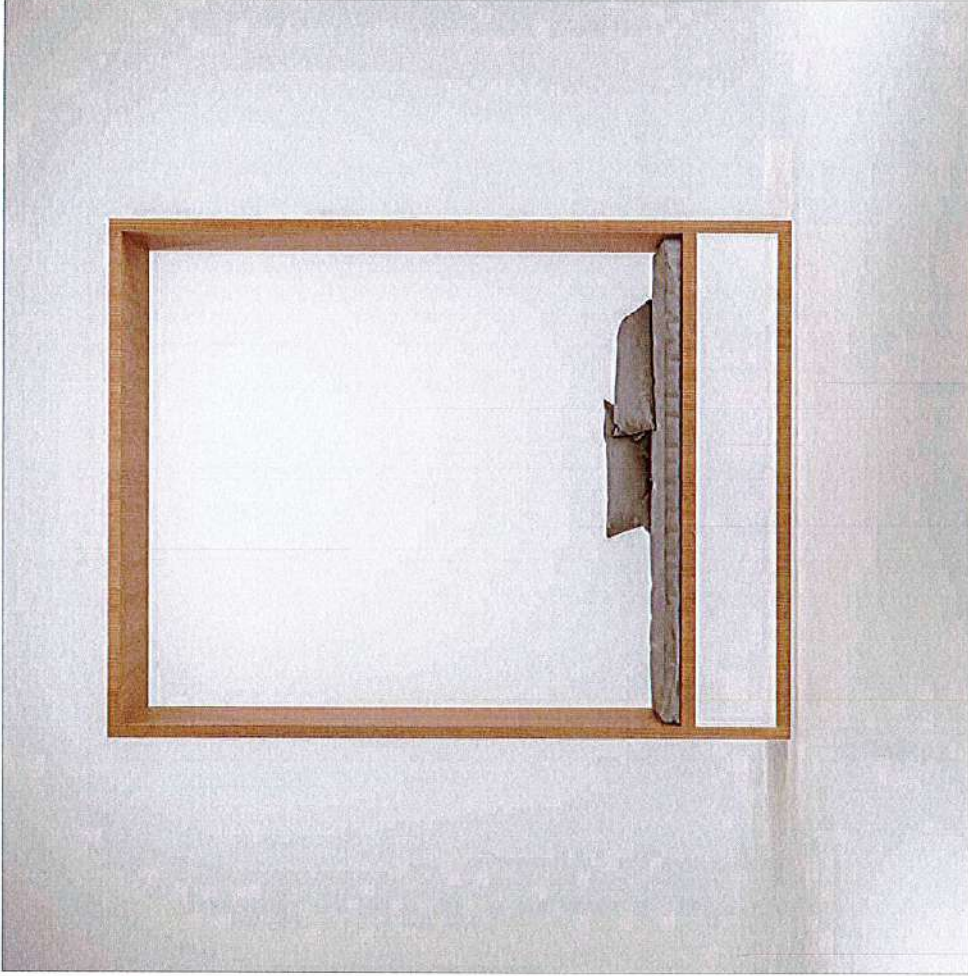


1.12 SEATER - 1  
SCALE 1:20

ID43

**NOTE**

- CL = CEILING LINE
- DCL = DROP CEILING LINE
- FFL = FLOOR FINISH LINE
- RFL = RAISED FLOOR LINE

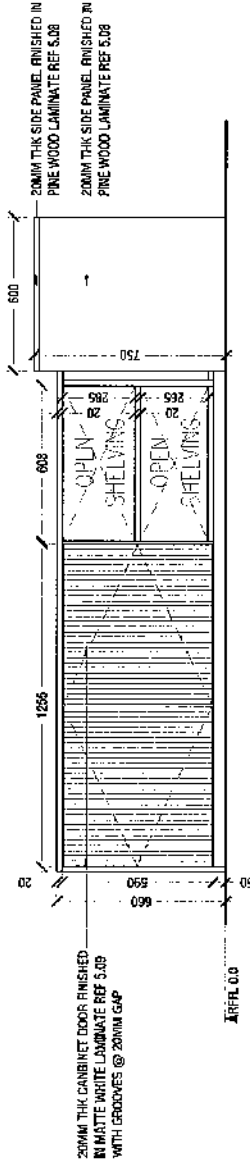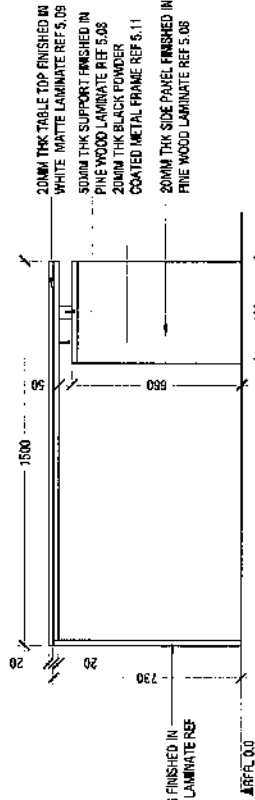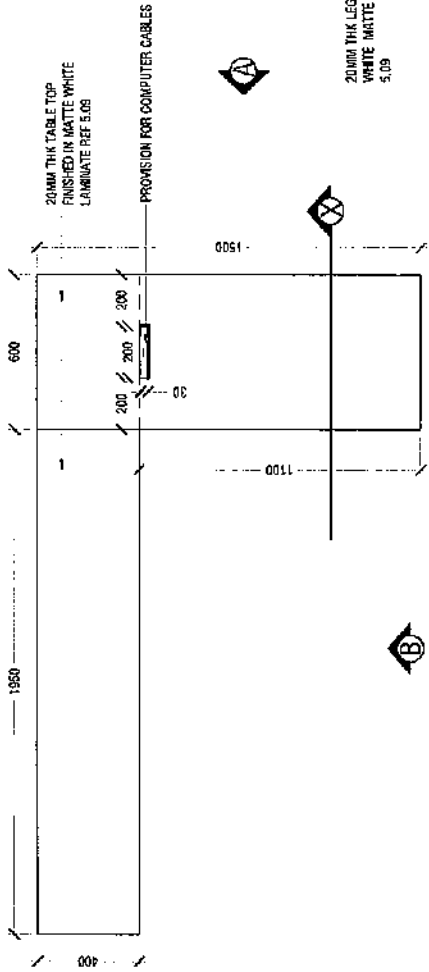

**MACO**  
DESIGNS

Contact: 7888966, 7801671

Email: info@maco.gov

0.6/21

JAUFAR RASHEED

PROJECT:

LUCKYLAST

AAADKULHAS

INTERIOR DESIGNER TEAM

MAAJID

ASIF

FAYYAZ

NILOOFAR

SCALE: AS SHOWN

DRAWING TITLE: AS GIVEN

DATE: 03/24/2021

REVISION NO.: 00

FILE NAME:


Y:\MACO\INTERIOR\LUCKYLAST\PROJECTS\LUCKYLAST\PROJECTS

LUCKYLAST.DWG

PLANTING



THIS DRAWING IS THE PROPERTY OF MACO DESIGNS. IT IS TO BE USED ONLY FOR THE PROJECT AND SITE SPECIFICALLY IDENTIFIED HEREIN. IT IS NOT TO BE REPRODUCED, COPIED, OR TRANSMITTED IN ANY FORM OR BY ANY MEANS, WITHOUT THE WRITTEN PERMISSION OF MACO DESIGNS. ANY UNAUTHORIZED USE OF THIS DRAWING IS STRICTLY PROHIBITED. ALL RIGHTS ARE RESERVED.

- CARCASS AND SHELVES FINISHED PINE WOOD LAMINATE REF 5.08 UNLESS SPECIFIED OTHERWISE

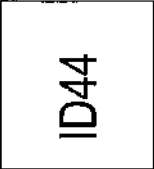

**NOTE**

- CL = CEILING LINE
- DCL = DROP CEILING LINE
- FFL = FLOOR FINISH LINE
- RFFL = RAISED FLOOR LINE

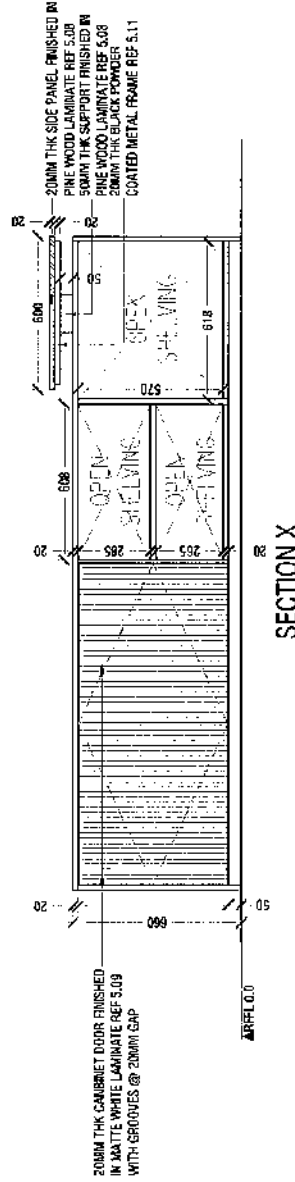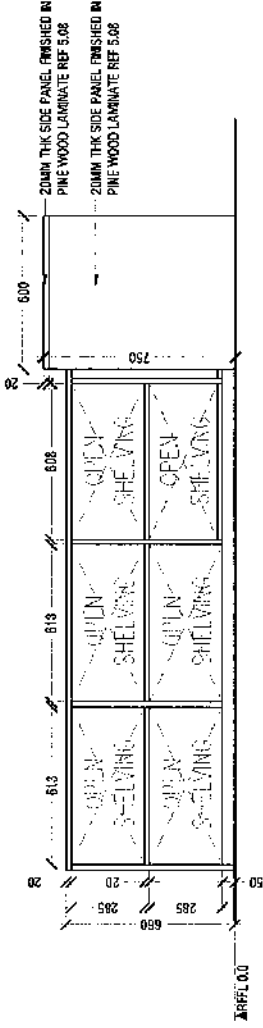

1.13 OFFICE DESK -3  
 SCALE 1:20

- BASE, CARCASS AND SHELVES FINISHED PINE WOOD LAMINATE REF 5.08 UNLESS SPECIFIED OTHERWISE

**AMCO**  
 D E S I G N S

Contact: 7989966, 7691671  
 Email: info@amco.my

CLIENT:

JAUFAR ROSHEED

PROJECT:

LUCKYLAST

AAULKULHAS

INTERIOR DESIGNER TEAM

NAJIB

ASIF

FATMA

WILCOFFER

SCALE: AS SHOWN

DRAWING TITLE: AS SHOWN

DATE: 03/01/2024

REVISION NO. 00

FILE NAME

AMCO-01-REDWOOD-AMCO

PROJECT: LUCKYLAST

PROJECT: LUCKYLAST

WARNING:

THIS DRAWING IS THE PROPERTY OF AMCO DESIGN S. IT IS TO BE USED ONLY FOR THE PROJECT AND SITE SPECIFICALLY MENTIONED HEREIN. IT IS NOT TO BE REPRODUCED, COPIED, OR TRANSMITTED IN ANY FORM OR BY ANY MEANS, ELECTRONIC OR MECHANICAL, INCLUDING PHOTOCOPYING, RECORDING, OR BY ANY INFORMATION STORAGE AND RETRIEVAL SYSTEM, WITHOUT THE WRITTEN PERMISSION OF AMCO DESIGN S.

**ID45**

CLIENT:

JAUFAR RASHEED

PROJECT:

LUCKYLAST

AA, UKULHAS

INTERIOR DESIGNER TEAM

MAAJID  
ASIF  
FAYYAH  
NILOOFAR

SCALE: AS GIVEN

DRWNG TITLE : AS GIVEN

DATE: 02/01/2021

REVISION NO. 02

FILE NAME:

001-PROJECTS\INTERIORS\PROJECTS  
2020\01\01\LUCKYLAST

WARNING:

1. THIS DRAWING IS THE PROPERTY OF MMCO. IT IS TO BE USED ONLY FOR THE PROJECT AND SITE SPECIFICALLY MENTIONED. ANY REUSE OR MODIFICATION OF THIS DRAWING WITHOUT THE WRITTEN PERMISSION OF MMCO IS STRICTLY PROHIBITED. ANY VIOLATION OF THIS WARNING WILL BE DEEMED AS A BREACH OF CONTRACT AND WILL BE PROSECUTED TO THE FULL EXTENT OF THE LAW.



NOTE

- CL = CEILING LINE
- DCL = DROP CEILING LINE
- FFL = FLOOR FINISH LINE
- RFFL = RAISED FLOOR LINE



Contact: 7889966, 7691671  
Email: info@mmco.my

CLIENT:  
JAUFAR RASHEED

PROJECT:  
LUCKYLAST

AAJUKULHAS

INTERIOR DESIGNER: TAM  
NAAJID  
ASIF  
FAYYAH  
NILOCFAR

SCALE: AS GIVEN

DRAWING TITLE: AS GIVEN

DATE: 02/04/2021



REVISION NO.: 00

FILE NAME:  
MMCO\DESIGN\MMCO\PROJECTS  
LUCKYLAST\LAMINATE

WARNING:  
THIS DRAWING HAS BEEN PREPARED  
AND ISSUED BY THE ARCHITECT  
OR ENGINEER IN CHARGE. THE USER  
HEREOF SHALL BE RESPONSIBLE FOR  
THE ACCURACY OF THE INFORMATION  
CONTAINED HEREIN. THE ARCHITECT  
OR ENGINEER IN CHARGE SHALL NOT  
BE RESPONSIBLE FOR ANY ERRORS  
OR OMISSIONS IN THIS DRAWING  
UNLESS SPECIFICALLY NOTED  
HEREON.

1.14 CABINET - 4  
SCALE 1:20

ID47

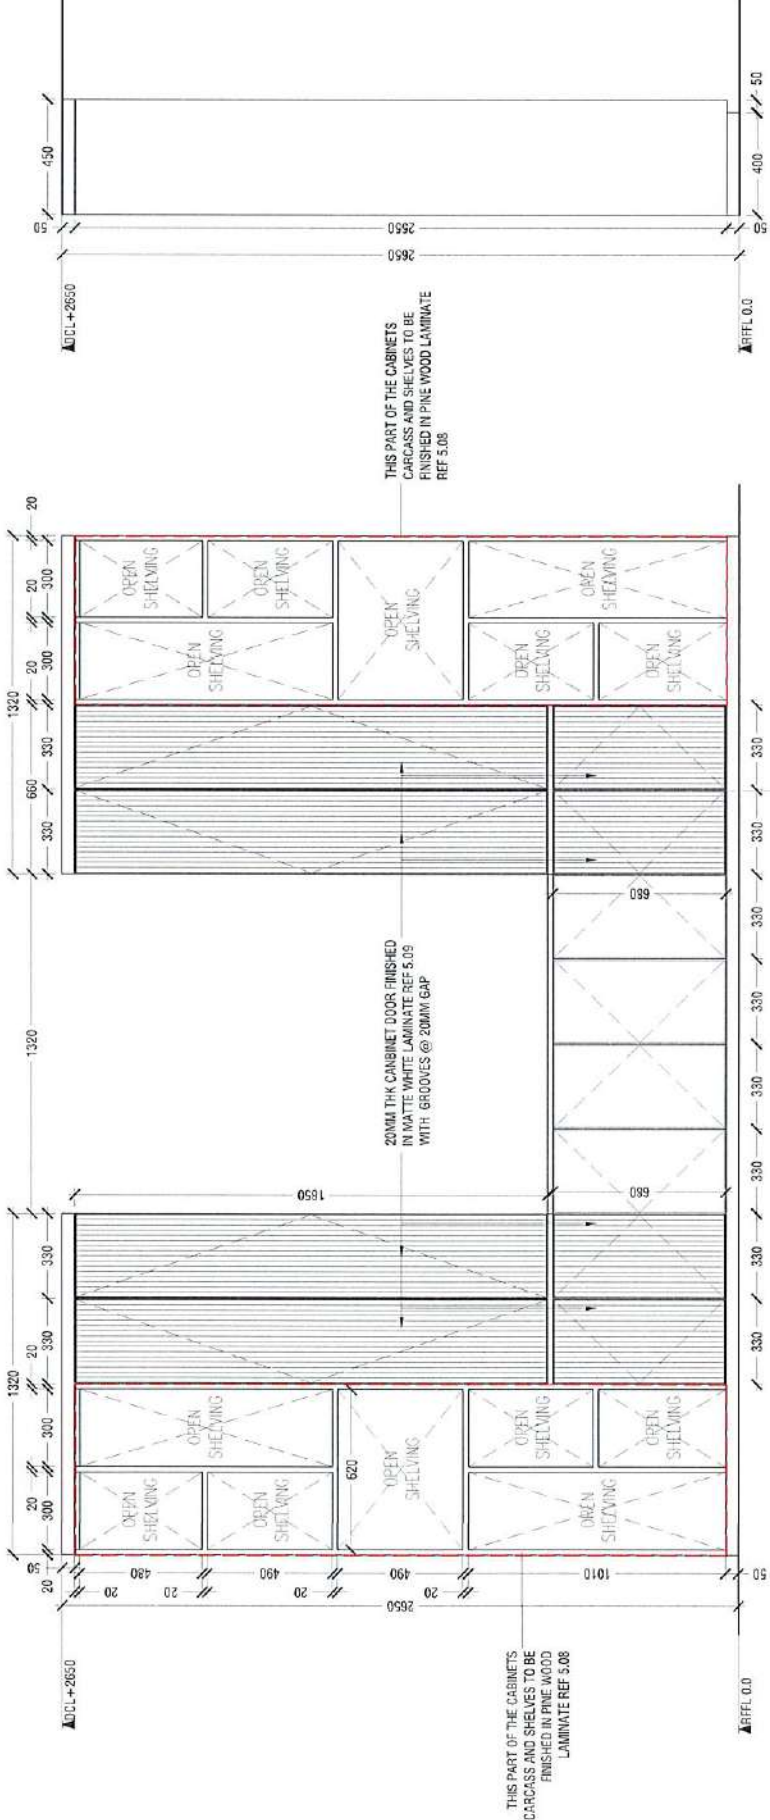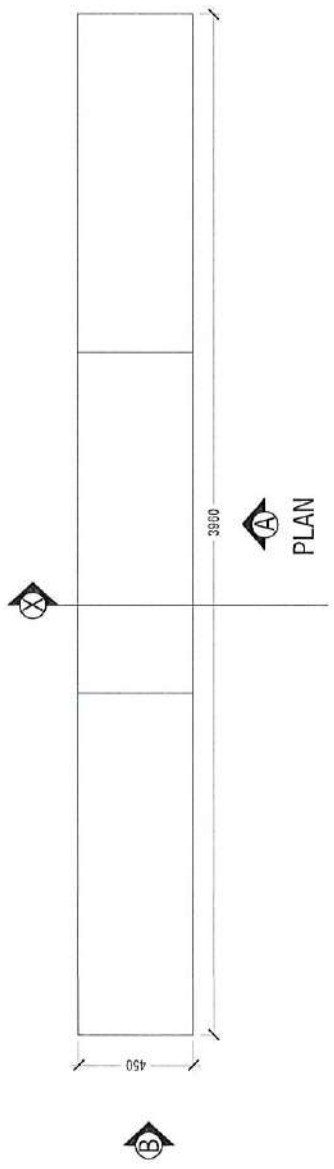

ELEVATION B

ELEVATION A

- TOP & BASE FINISHED IN MATTE WHITE LAMINATE REF 5.09
- HINGE DOORS FINISHED IN MATTE WHITE LAMINATE RE 5.09
- UNLESS SPECIFIES OTHERWISE
- CARCASS AND SHELVES FINISHED MATTE WHITE LAMINATE REF 5.09
- UNLESS SPECIFIED OTHERWISE



NOTE

- CL = CEILING LINE
- DCL = DROP CEILING LINE
- FFL = FLOOR FINISH LINE
- RFFL = RAISED FLOOR LINE



Contact: 7989866, 7691671  
Email: info@mamo.mv

CLIENT: JAUFAR RASHEED

PROJECT: LUCKYLAST

AA.UKULHAS

INTERIOR DESIGNER TEAM

NAAJID  
ASIF  
FAYYAH  
NILOOFAR

SCALE: AS GIVEN

DRAWING TITLE : AS GIVEN

DATE : 02/04/2021


REVISION NO. 00

FILE NAME:  
MAMO\SUB\DESIGN\PROJECTS  
PROJECTS\INTERIOR PROJECTS

WARNING: This drawing is not to scale for construction

Copyright © 2021 MAMO DESIGNS. All rights reserved. No part of this drawing may be reproduced, stored in a retrieval system, or transmitted in any form or by any means, electronic, mechanical, photocopying, recording, or otherwise, without the prior written permission of MAMO DESIGNS. This drawing is the property of MAMO DESIGNS and shall remain the property of MAMO DESIGNS. All other rights reserved.

ID48

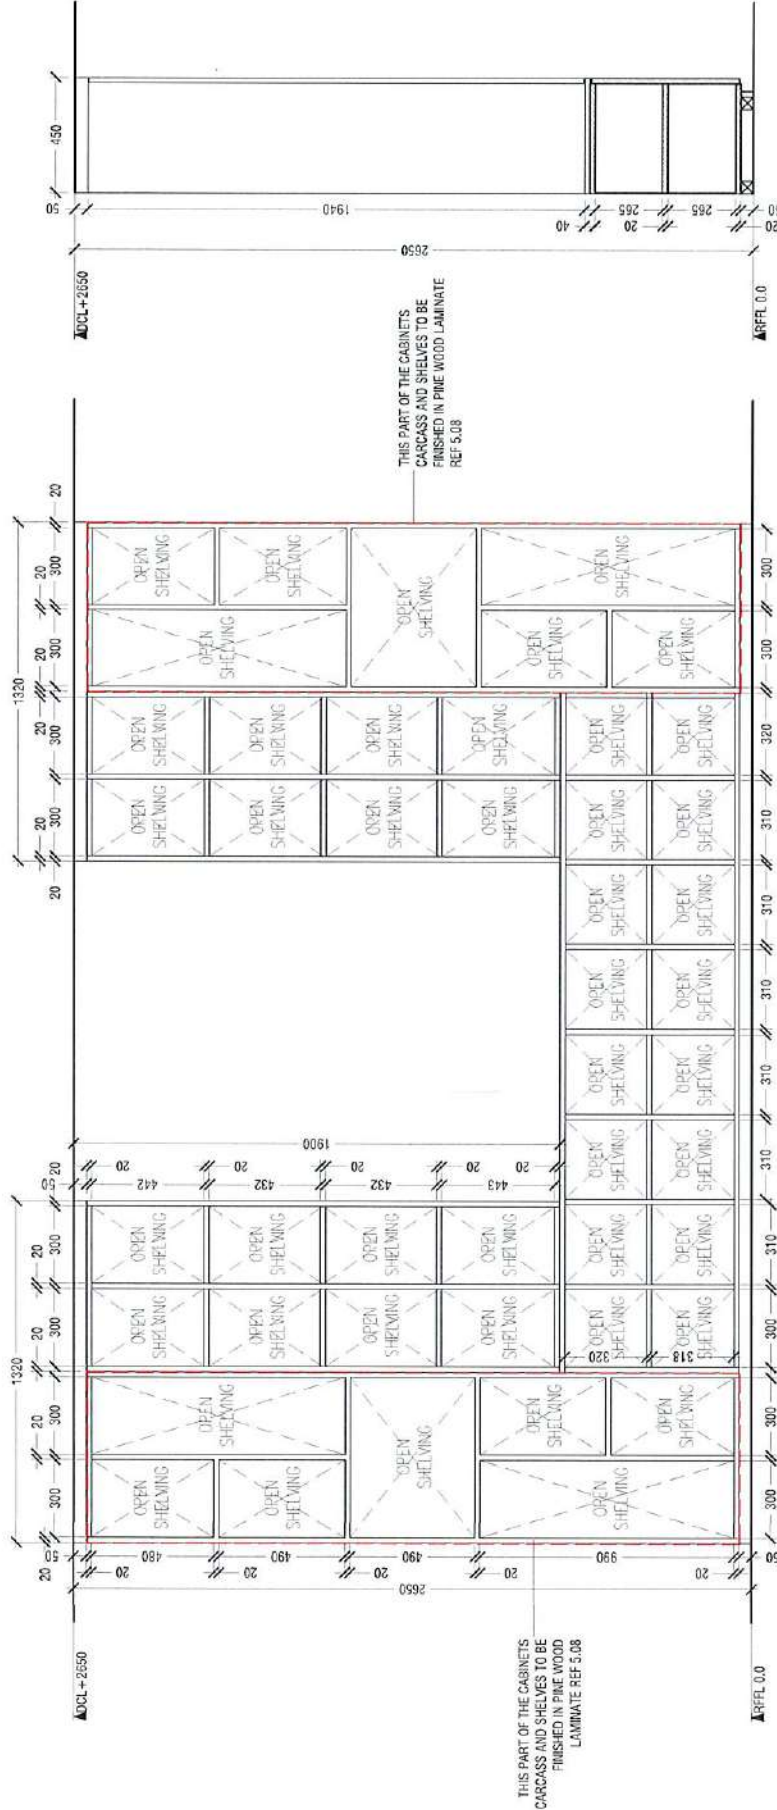

OPEN ELEVATION A


- TOP & BASE FINISHED IN MATTE WHITE LAMINATE REF 5.09
- HINGE DOORS FINISHED IN MATTE WHITE LAMINATE RE 5.09
- UNLESS SPECIFIES OTHERWISE
- CARCASS AND SHELVES FINISHED MATTE WHITE LAMINATE REF 5.09
- UNLESS SPECIFIED OTHERWISE

1.14 CABINET - 4  
SCALE 1:20




**NOTE**


- CL = CEILING LINE
- DCL = DROP CEILING LINE
- FFL = FLOOR FINISH LINE
- RFFL = RAISED FLOOR LINE

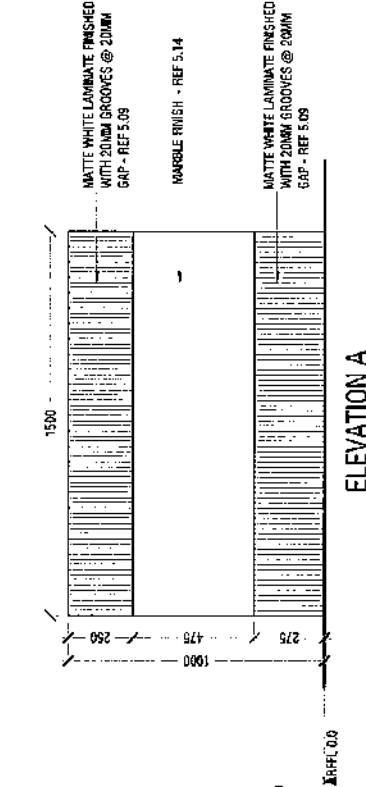


**ELEVATION A**

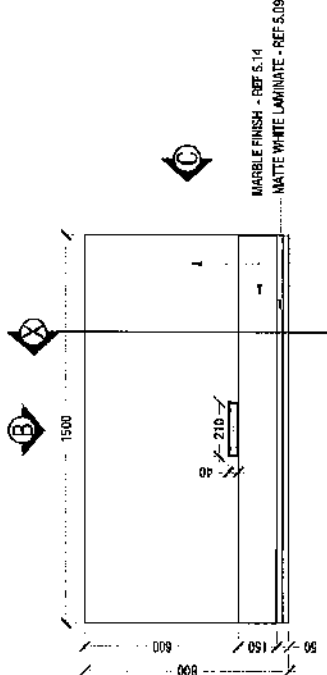


**PLAN**

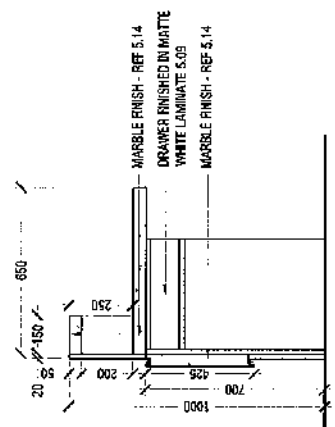

**SECTION X**

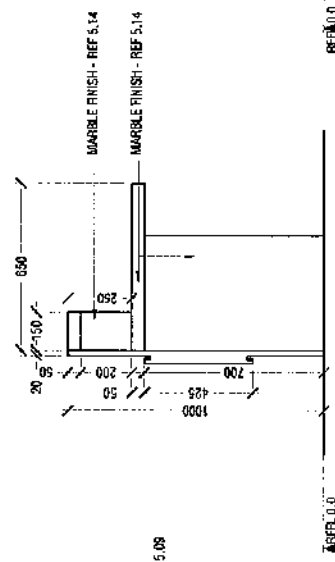

**ELEVATION C**

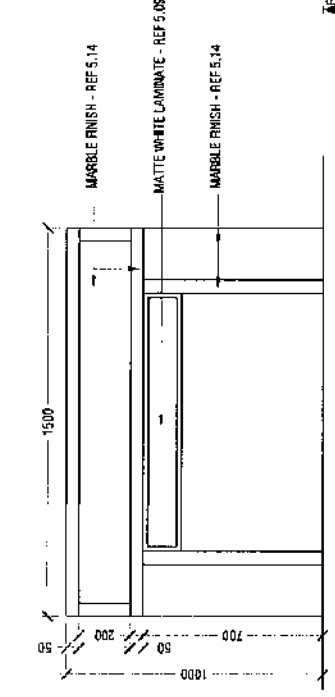

**ELEVATION B**

**AMACO**  
DESIGNS  
Contact: 7969866, 7691671  
Email: info@amaco.my

CLIENT: JAUJAR RASHHEED  
PROJECT: LUCKYLAST  
AA-LUKULHAS  
ARCHITECTURE DESIGNER TEAM  
NAAJID  
ASIF  
FAYYAH  
NILOOFAR

SCALE: AS GIVEN  
DRAWING TITLE: AS GIVEN  
DATE: 23/04/2024  
REVISION NO.: 00  
FILE NAME: 1.15-RECEPTION DESK  
PROJECT: LUCKYLAST PROJECTS  
ARCHITECTURE DESIGNER TEAM

**WARNING:**  
This drawing is the property of AMACO DESIGNS and is to be used only for the project and location specified. It is not to be used for any other project or location without the written consent of AMACO DESIGNS. All rights reserved.

**1.15** RECEPTION DESK  
SCALE 1:20

**ID50**

**MACO**  
DESIGNS  
Contact: 7989366, 7691671  
Email: info@maco.my

CURT:  
**JAUFAR RASHEED**

PROJECT:  
**LUCKYLAST**  
**AAUKULHAS**

INTERIOR DESIGNER/TEAM:  
NAALID  
ASIF  
FAYYAH  
NILDIPAR


SCALE: AS GIVEN

DRIVING TITLE: AS GIVEN  
DATE: 02/04/2021

REVISION NO. 06

FILE NAME:  
20210402110103\jufar\_rasheed\_maco  
20210402110103\jufar\_rasheed\_maco

WORKING

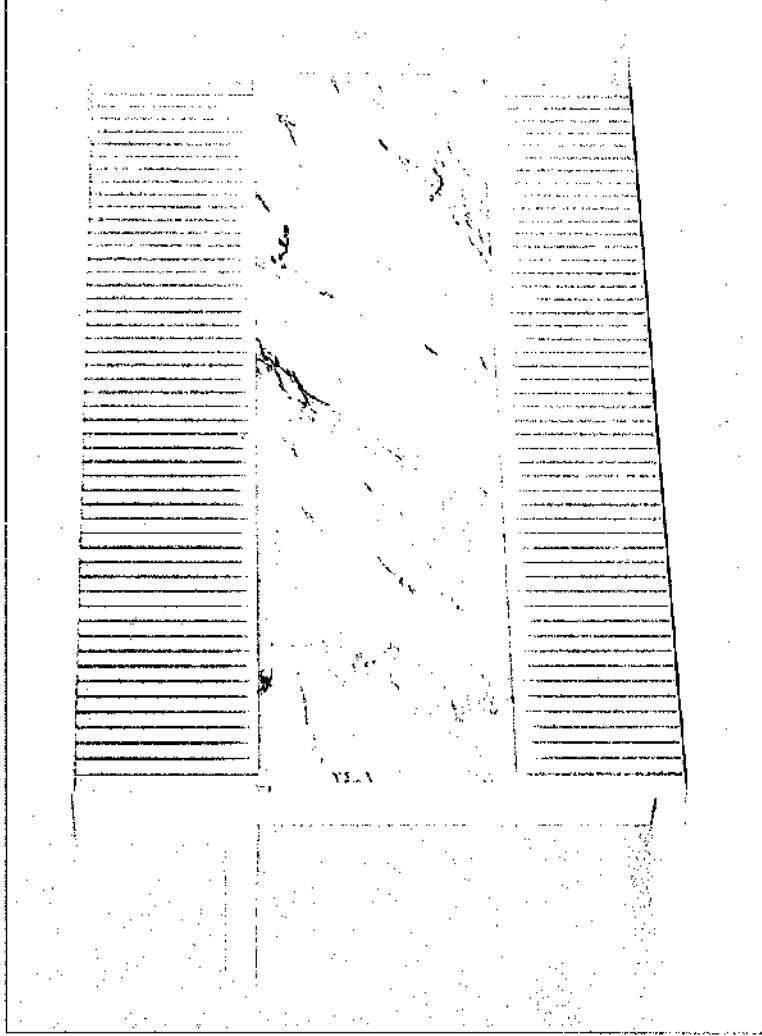


1.15 RECEPTION DESK  
SCALE 1:20


ID51

**NOTE**


- CL = CEILING LINE
- DCL = DROP CEILING LINE
- FFL = FLOOR FINISH LINE
- RFFL = RAISED FLOOR LINE

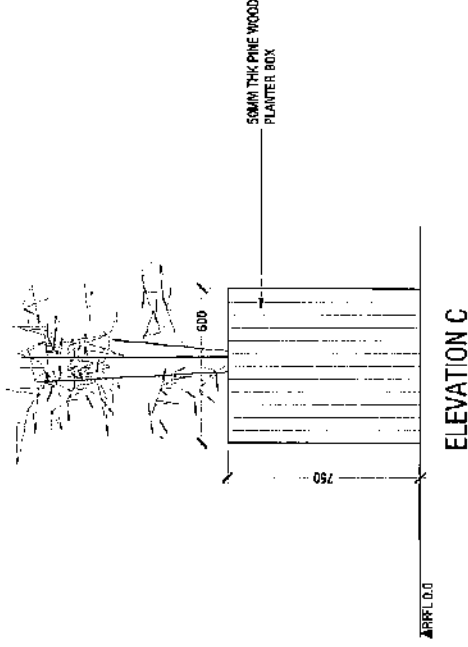


**ELEVATION C**

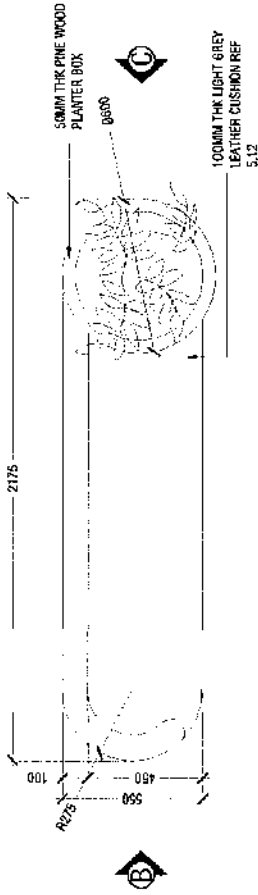

**PLAN**

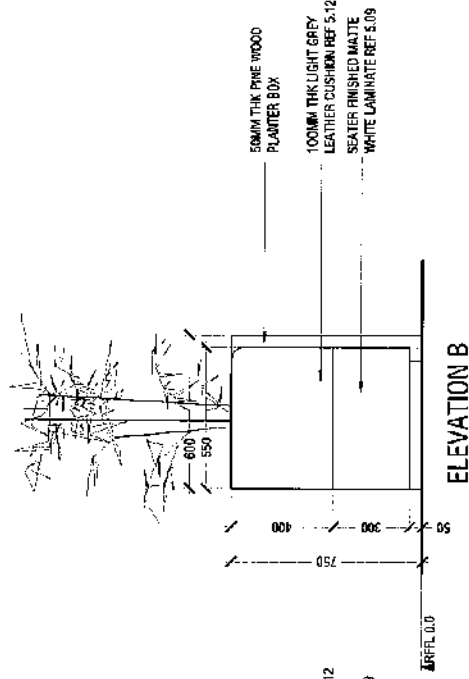

**ELEVATION B**

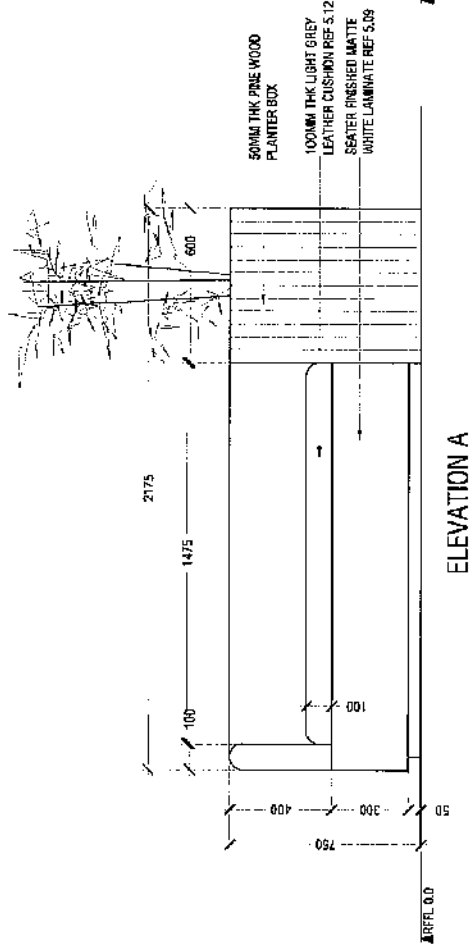

**ELEVATION A**

**MACO**  
DESIGNS

Contact: 79899566, 7691671

Email: info@maco.my

CLIENT:

JAUJAR RASHEED

PROJECT:

LUCKYLAST

AA LUKULHAS

INTERIOR DESIGNER TEAM

NAALID

ASIP

FAYYAH

NILOOFAR

SCALE: AS GIVEN

DRAWING TITLE: AS GIVEN

DATE: 09/05/2021

REVISION NO: 00

FILE NAME:

PROJECT NAME: NEW PROJECTS

APP: 10/05/2021 10:00:00

PROJECT NUMBER: 00000000000000000000

PROJECT LOCATION: 00000000000000000000

PROJECT STATUS: 00000000000000000000

PROJECT TYPE: 00000000000000000000

PROJECT VALUE: 00000000000000000000

PROJECT START DATE: 00000000000000000000

PROJECT END DATE: 00000000000000000000

PROJECT MANAGER: 00000000000000000000

PROJECT COORDINATOR: 00000000000000000000

PROJECT ARCHITECT: 00000000000000000000

PROJECT ENGINEER: 00000000000000000000

PROJECT SURVEYOR: 00000000000000000000

PROJECT CONTRACTOR: 00000000000000000000

PROJECT SUBCONTRACTOR: 00000000000000000000

PROJECT CONSULTANT: 00000000000000000000

PROJECT ADVISOR: 00000000000000000000

**ID52**

**1.16** SOFA WITH PLANTER -2  
SCALE 1:20



**MACO**  
DESIGNS

Contact: 7989966, 7691671  
Email: info@maco.my

CLIENT:

JAUFAR RASHEED

PROJECT:

LUCKYLAST

AA.UKULHAS

INTERIOR DESIGNER TEAM

NAAJID

ASIF

FAYYAH

NILOOFAR

SCALE: AS GIVEN

DRAWING TITLE : AS GIVEN

DATE: 02/01/2021

REVISION NO. 00

FILE NAME:

AA.UKULHAS/SHAHA - IMRAN/2  
PROJECTS/INTERIOR PROJECTS  
PROJECTS/AA.UKULHAS

WARNING:

This drawing shall not be used for construction without the written consent of MACO DESIGNS. The client shall be responsible for the accuracy of the information provided. The client shall be responsible for the accuracy of the information provided. The client shall be responsible for the accuracy of the information provided.

1.16 SOFA WITH PLANTER -2  
SCALE 1:20

ID53



**NOTE**

- CL = CEILING LINE
- DCL = DROP CEILING LINE
- FFL = FLOOR FINISH LINE
- RFFL = RAISED FLOOR LINE

**AMACO**  
O E S T I M A T I O N S

Contact: 79899665, 7691871

Email: info@amaco.my

CLIENT:

JAUFAR RASHEED

PROJECT:

LUCKYLAST

AAUKULFIAS

INTERIOR DESIGNER TEAM:

HAKJUD

ASIF

FARAH

RILLOFFAR

SCALE AS GIVEN

DRAWING TITLE : AS GIVEN

DATE : 02/01/2021

REVISION NO. : 00

FILE NAME :

MANUFACTURER NAME : WAKEL


MANUFACTURER ADDRESS :

PRODUCTION NUMBER :


WARNING:

1. THIS DRAWING IS THE PROPERTY OF AMACO. IT IS TO BE USED ONLY FOR THE PROJECT AND SITE SPECIFICALLY MENTIONED HEREIN. IT IS NOT TO BE REPRODUCED, COPIED, OR TRANSMITTED IN ANY FORM OR BY ANY MEANS, ELECTRONIC OR MECHANICAL, INCLUDING PHOTOCOPYING, RECORDING, OR BY ANY INFORMATION STORAGE AND RETRIEVAL SYSTEM, WITHOUT THE WRITTEN PERMISSION OF AMACO.

**1.17** CABINET - 5  
SCALE 1:20

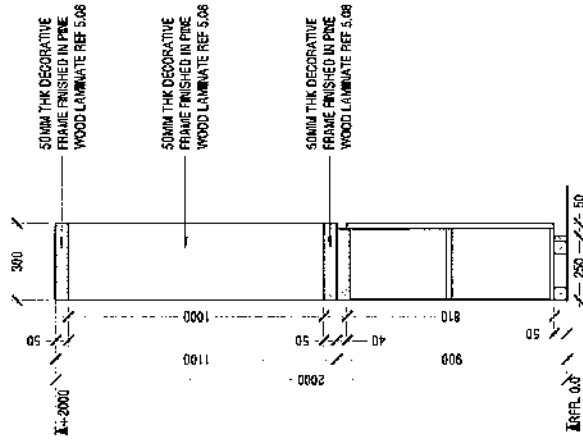

**SECTION X**

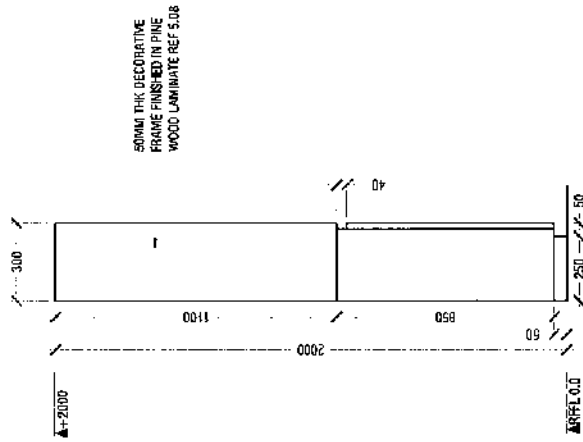

**ELEVATION B**

- TOP & BASE FINISHED IN PINE WOOD LAMINATE REF 5.08
- HINGE DOORS FINISHED IN MATT WHITE LAMINATE REF 5.09
- CARCASS AND SHELVES FINISHED PINE WOOD LAMINATE REF 5.08


**ID55**






NOTE

- CL = CEILING LINE
- DCL = DROP CEILING LINE
- FFL = FLOOR FINISH LINE
- RFFL = RAISED FLOOR LINE

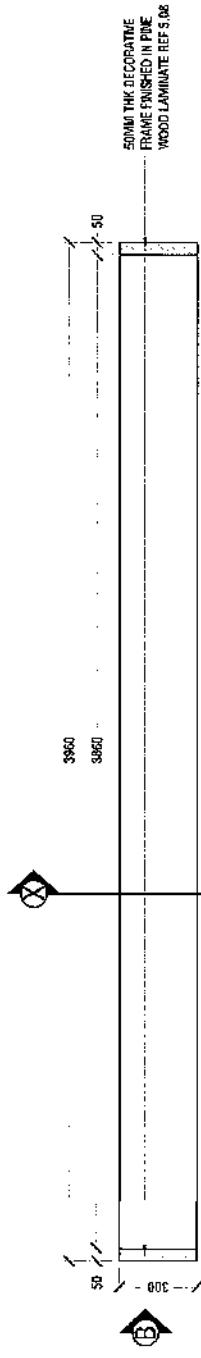


PLAN

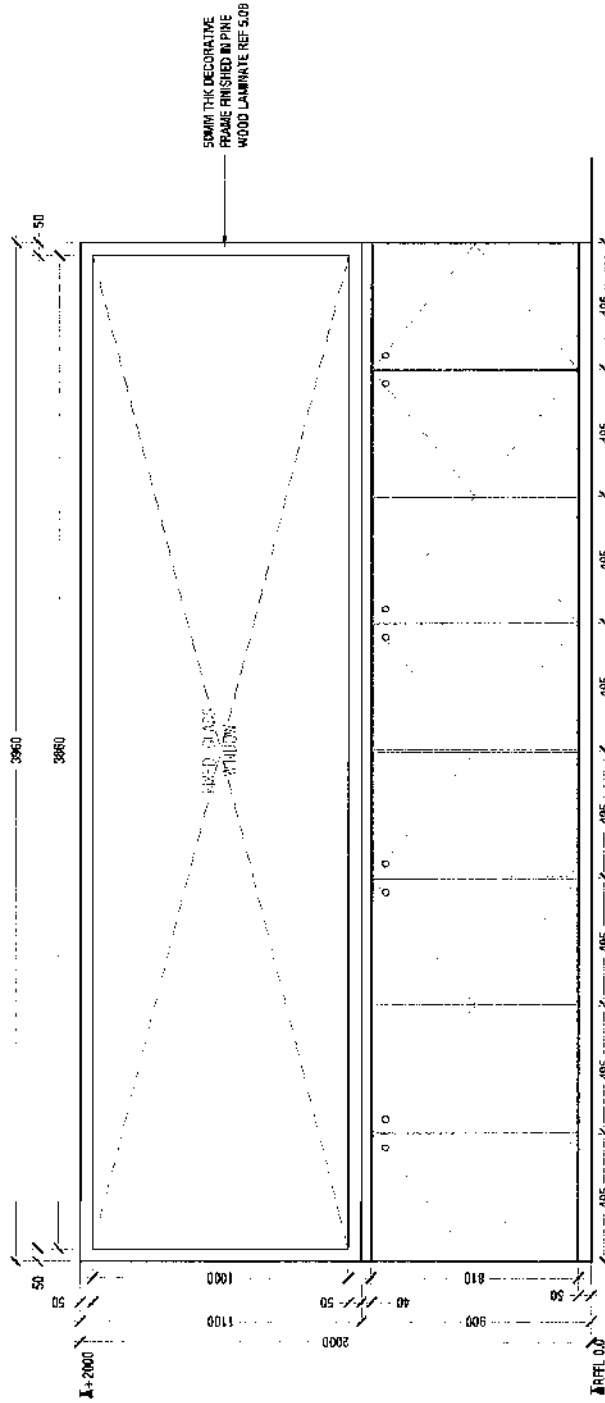

ELEVATION A

- TOP & BASE FINISHED IN PINE WOOD LAMINATE REF 5.08
- HINGE DOORS FINISHED IN MATT WHITE LAMINATE REF 5.09
- CARCASS AND SHELVES FINISHED PINE WOOD LAMINATE REF 5.08

 1.18 CABINET - 6  
SCALE 1:20



Contact: 79869966, 76616771  
Email: info@amco.my

CLIENT:  
JAUFAR RASHEED

PROJECT:  
LUCKYLAST

AAJUKULHAS

INTERIOR DESIGNER TEAM  
NAAJUD  
ASIF  
CIVILAH  
NUSOFAR

SCALE: AS GIVEN

DRAWING TITLE : AS GIVEN


DATE: 02/04/2023

REVISION NO.

FILE NAME:

USER: DESIGNER\_TEAM  
PROJECT: LUCKYLAST  
DRAWING: INTERIORS


WARNING:  
THIS DRAWING IS THE PROPERTY OF AMCO DESIGNS. IT IS TO BE USED ONLY FOR THE PROJECT AND SITE SPECIFICALLY MENTIONED HEREIN. IT IS NOT TO BE REPRODUCED, COPIED, OR TRANSMITTED IN ANY FORM OR BY ANY MEANS, ELECTRONIC OR MECHANICAL, WITHOUT THE WRITTEN PERMISSION OF AMCO DESIGNS.

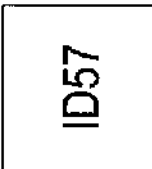


**NOTE**

- CL = CEILING LINE
- DCL = DROP CEILING LINE
- FFL = FLOOR FINISH LINE
- RFFL = RAISED FLOOR LINE

50MM THK DECORATIVE  
FRAME FINISHED IN PINE  
WOOD LAMINATE REF 5.08

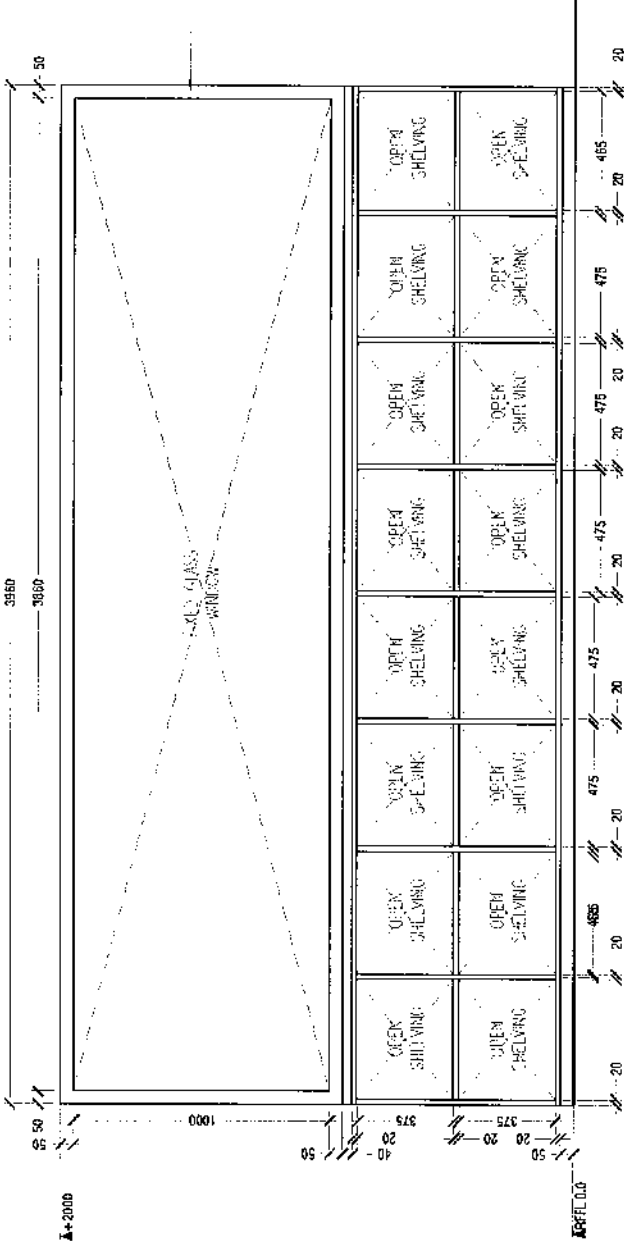

**OPEN ELEVATION A**

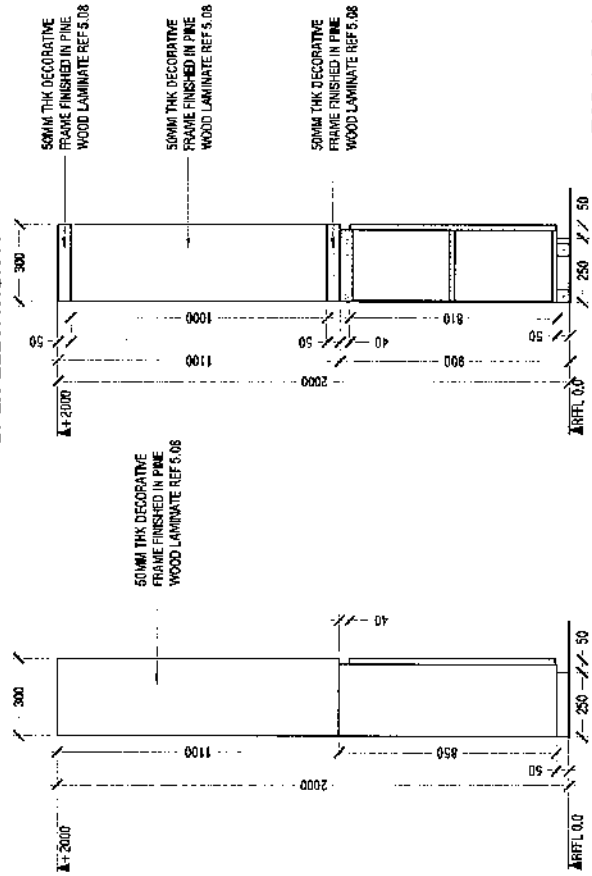

**ELEVATION B**

**SECTION X**

**1.18** CABINET - 6  
SCALE 1:20

TOP & BASE FINISHED IN PINE WOOD LAMINATE REF 5.08  
HINGE DOORS FINISHED IN MATT WHITE LAMINATE REF 5.09  
CARCASS AND SHELVES FINISHED PINE WOOD LAMINATE REF 5.08

**MACO**  
DESIGNS

Contact: 7989666, 7691671  
Email: info@maco.my

CLIENT

JALIFAR RASHEED

PROJECT

LUCKYLAST

AAUKULHAS

INTERIOR DESIGNER TEAM

MAALID

ASIF

FATYAH

NILOOFAR

SCALE: AS SHOWN

DRAWING TITLE: AS GIVEN

DATE: 02/01/2021

REVISION NO. 00

ELECTRICAL

MECHANICAL

PLUMBING

PAINTING

ROOFING

SCAFFOLDING

DEMOLITION

FOUNDATION

STRUCTURE

MECHANICAL

ELECTRICAL

PAINTING

ROOFING

SCAFFOLDING

DEMOLITION

FOUNDATION

STRUCTURE

MECHANICAL

ELECTRICAL

PAINTING

ROOFING

SCAFFOLDING

DEMOLITION

FOUNDATION

**ID58**

**MACO**  
DESIGNS

Contact: 7989986, 7691671  
Email: info@maco.my

CUSTOMER:

JAUFAR RASHEED

PROJECT:

LUCKYLAST

AA.LUKLIHAS

INTERIOR DESIGNER TEAM

NAAJUD

ASIF

FAYYAH

NILLOOFAR

SCALE: AS SHOWN

DRAWING TITLE: /AS GWN

DATE: 02/01/21


REVISION NO.: 00

FILE NAME:

AA.LUKLIHAS.MACO  
PROJECTS\INTERIOR PROJECTS  
AA.LUKLIHAS\AA.LUKLIHAS

WARNING:

This drawing is for information only. It is not to be used for construction. The client is responsible for providing all necessary information and approvals. The client is responsible for providing all necessary information and approvals. The client is responsible for providing all necessary information and approvals.

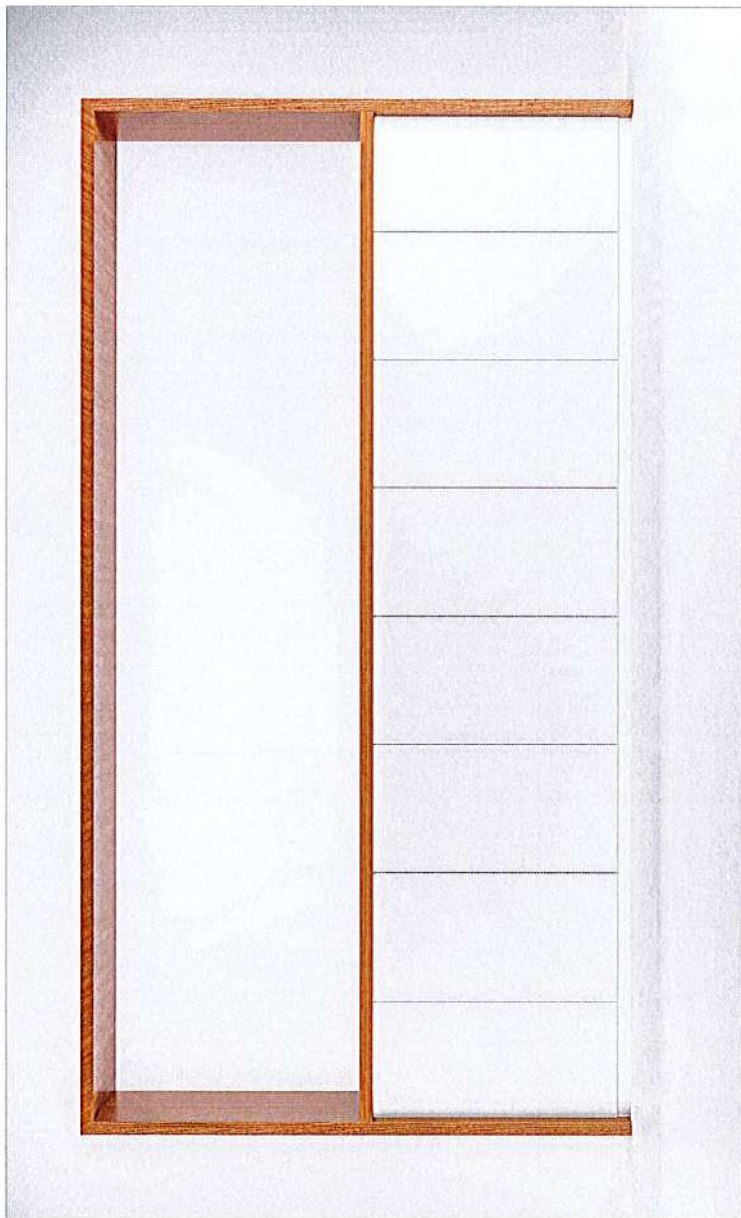



1.18 CABINET - 6  
SCALE 1:20

ID59



**NOTE**

- CL = CEILING LINE
- DCL = DROP CEILING LINE
- FFL = FLOOR FINISH LINE
- RFFL = RAISED FLOOR LINE



- 50MM THK BLACK POWDER COATED METAL FRAME IN ALL PARTITIONS
- FROSTED GLASS PANELS IN ALL PARTITIONS

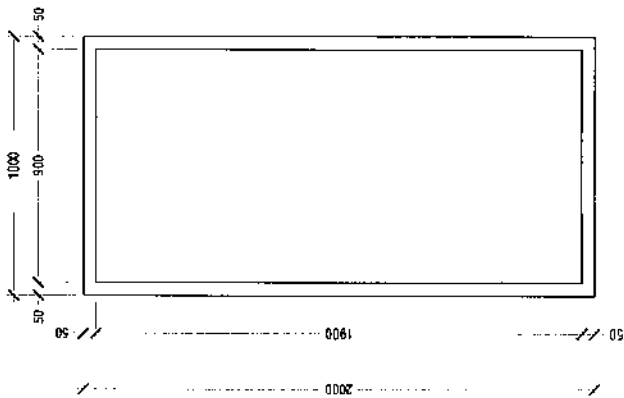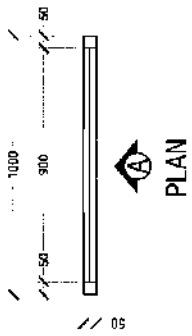

**P1** GLASS PARTITION DETAILS  
SCALE 1:20

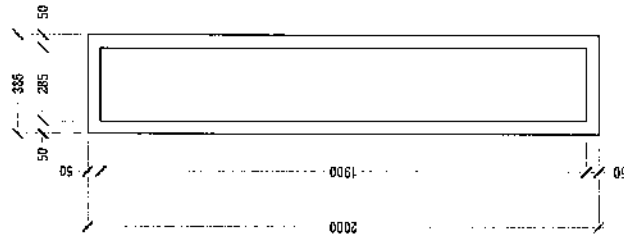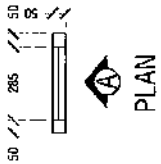

**P2** GLASS PARTITION DETAILS  
SCALE 1:20

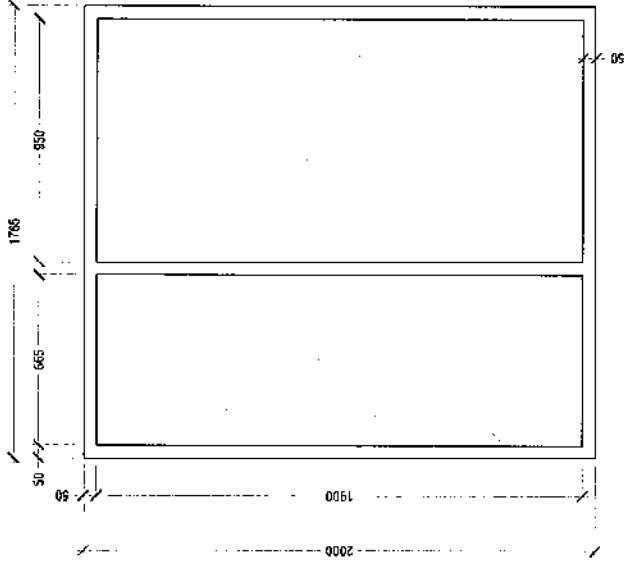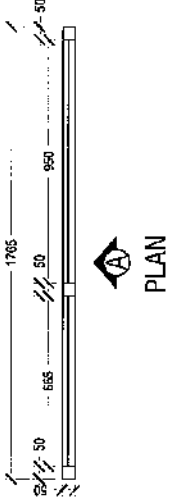

**P3** GLASS PARTITION DETAILS  
SCALE 1:20

**MACO**  
DESIGNS  
Contact: 7898956, 7691671  
Email: info@maco.my

CLIENT:  
**JAUFAR RASHEED**

PROJECT:  
**LUCKYLAST**

AAUKULHAS

INTERIOR DESIGNER TEAM:  
HAJJID  
ASIF  
FAYYAH  
MILLOFAR


SCALE: AS GIVEN  
DRAWING TITLE: AS GIVEN  
DATE: 02/01/2021  
ARCHITECT NO.: 00

FILE NAME:  
D:\PROJECTS\LUCKYLAST\LUCKYLAST\LUCKYLAST.DWG


WARNING:  
This drawing is the property of MACO DESIGNS. It is not to be used, copied, or reproduced in any form without the written consent of MACO DESIGNS. The user of this drawing is responsible for its use and any consequences thereof.

**ID60**

 - 50MM THK BLACK POWDER COATED METAL FRAME IN ALL PARTITIONS
- FROSTED GLASS PANELS IN ALL PARTITIONS



PLAN

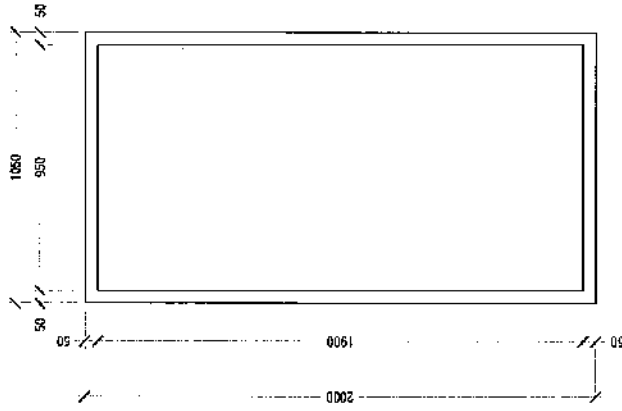


ELEVATION A


P4 GLASS PARTION DETAILS  
SCALE 1:20

NOTE

 - CL = CEILING LINE
- DCL = DROP CEILING LINE
- FFL = FLOOR FINISH LINE
- RFFL = RAISED FLOOR LINE




PLAN

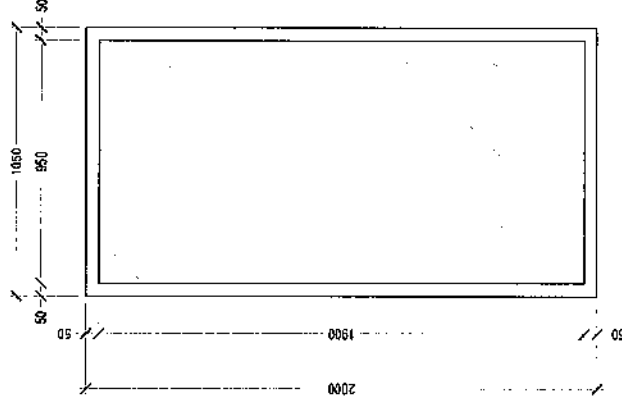

ELEVATION A

 P5 GLASS PARTION DETAILS  
SCALE 1:20



Contact: 79889668, 7601671  
Email: info@mco.idv

CLIENT

JAUFAR RASHEED

PROJECT

LUCKYLAST

AAUKULHAS

INTERIOR DESIGNER TEAM

NAAJID

ASIF

FAYYAH

NILDOFAR

SCALE AS SHOWN

DRIVING TITLE : AS GIVN

DATE : 02/04/2022

REVISION NO. : 05

RECLAME


MEMORANDUM: SIMAS



PROPOSITION FOR PROJECTS

INTI TUNAS BERKUALITI



MAKING:

MEMORANDUM: SIMAS  
PROPOSITION FOR PROJECTS  
INTI TUNAS BERKUALITI  
MAKING:

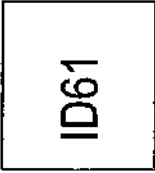

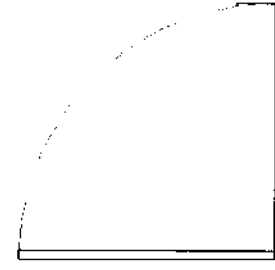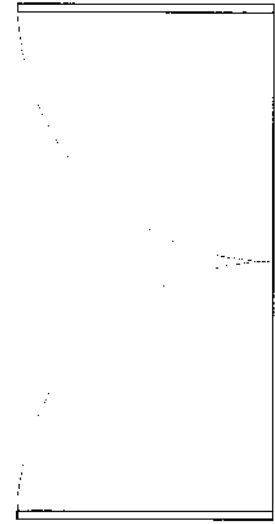

- NOTE:
- T-TIMBER
  - G-GLASS
  - TG-TEMPERED GLASS
  - TL-TIMBER LOUVERED
  - GL-GLASS LOUVERED
  - AL-ALUMINIUM LOUVERED
  - A-ALLUMINIUM
  - PVC-PLASTIC
  - S.S- STAINLESS STEEL
  - FB-FIBER BOARD
  - F.G-FROST GLASS

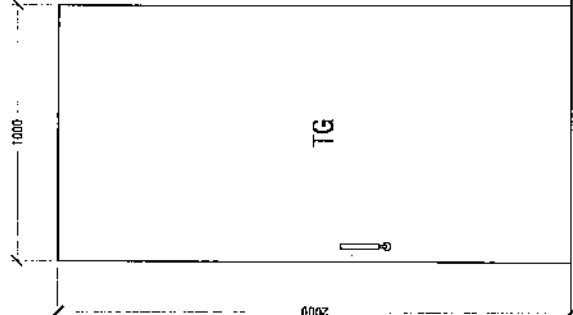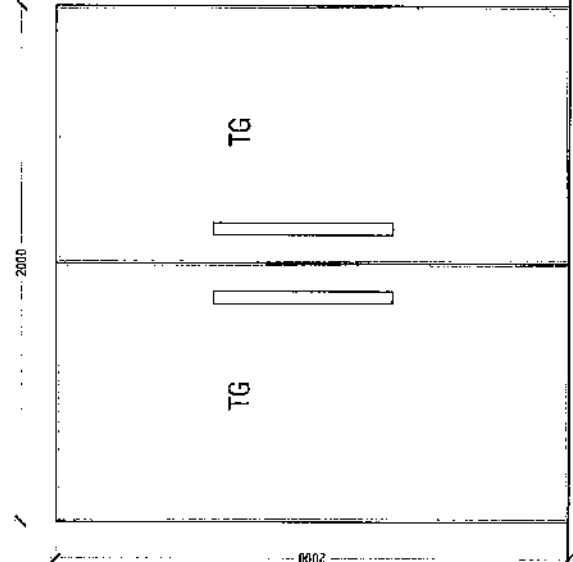

RFFL

- GLASS DOOR PANEL
- STAINLESS STEEL LOCK AND DOOR HANDLE
- GLASS DOOR PANEL
- DOOR HANDLE FINISHED IN BLACK POWDER COATED
- STAINLESS STEEL LOCK AND DOOR HANDLE

D01  
SCALE 1:20

D02  
SCALE 1:20

**AMACO**  
DESIGNS  
Contact: 7989988, 7691871  
Email: info@amaco.my

CUSTOMER:  
JAUFAR RASHEED

PROJECT:  
LUCKYLAST  
AAJUKULHAS

INTERIOR DESIGNER TEAM  
NAAJID  
ASIF  
FRYHAN  
NICOOPAR

SCALE: AS GIVEN

DRAWING TITLE: AS GIVEN

DATE: 02/01/2024





REVISION NO. 01

FILE NAME:  
D:\PROJECTS\LUCKYLAST\LUCKYLAST-INDOOR PRODUCTS  
INDOOR PRODUCTS\LUCKYLAST.DWG

NOTES:  
1. ALL DIMENSIONS ARE IN METERS UNLESS OTHERWISE SPECIFIED.  
2. ALL DIMENSIONS ARE TO FACE UNLESS OTHERWISE SPECIFIED.  
3. ALL DIMENSIONS ARE TO CENTERLINE UNLESS OTHERWISE SPECIFIED.  
4. ALL DIMENSIONS ARE TO CENTERLINE UNLESS OTHERWISE SPECIFIED.  
5. ALL DIMENSIONS ARE TO CENTERLINE UNLESS OTHERWISE SPECIFIED.

ID62

- NOTE:  
 T-TIMBER  
 G-GLASS  
 TG-TEMPERED GLASS  
 TL-TIMBER LOUVERED  
 GL-GLASS LOUVERED  
 AL-ALUMINIUM LOUVERED  
 A-ALLUMINIUM  
 PVC-PLASTIC  
 S.S- STAINLESS STEEL  
 FB-FIBER BOARD  
 F.G-FROST GLASS

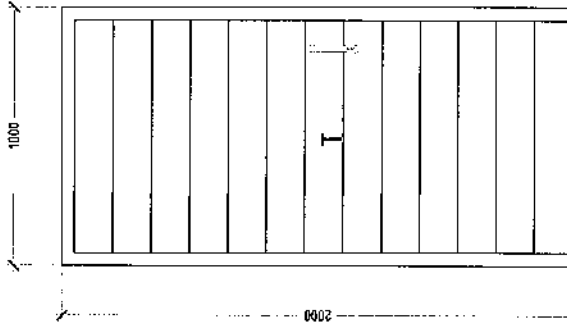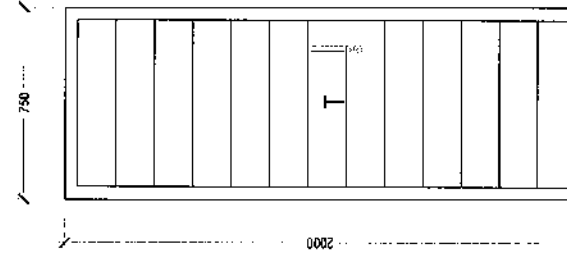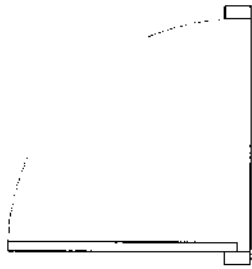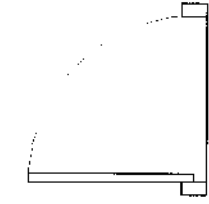

- TIMBER FRAME
- TIMBER DOOR PANEL
- STAINLESS STEEL LOCK
- DOOR HANDLE FINISHED IN BLACK POWDER COATED STAINLESS STEEL

D3 DOOR-3  
 SCALE 1:20

- TIMBER FRAME
- TIMBER DOOR PANEL
- STAINLESS STEEL LOCK
- DOOR HANDLE FINISHED IN BLACK POWDER COATED STAINLESS STEEL

D4 DOOR-4  
 SCALE 1:20

**MACO**  
 D E S I G N S  
 Contact: 988966, 7691871  
 Email: info@maco.my

CLIENT:  
**JAUFAR RASHEED**

PROJECT:  
**LUCKYLAST**

AA.LUKLIHAS

INTERIOR DESIGNER TEAM  
 NAAJID  
 ASIF  
 FAYYAH  
 NILDOOFAR

SCALE: AS SHOWN  
 DRAWING TITLE: AS GIVEN  
 DATE: 03/01/2021  
 REVISION NO. 00

BY: MACO  
 PROJECT MANAGER: MACO  
 PROJECT COORDINATOR: PROJECTS  
 PROJECT SUPPORT: PROJECTS


WARNING:  
 THIS DRAWING IS THE PROPERTY OF MACO DESIGN S. ANY REPRODUCTION OR DISTRIBUTION OF THIS DRAWING WITHOUT THE WRITTEN PERMISSION OF MACO DESIGN IS STRICTLY PROHIBITED. ANY BREACH OF THIS WARNING WILL BE PROSECUTED TO THE FULL EXTENT OF THE LAW.

**ID63**

RFFL



- NOTE:  
 T-TIMBER  
 G-GLASS  
 TG-TEMPERED GLASS  
 TL-TIMBER LOUVERED  
 GL-GLASS LOUVERED  
 AL-ALUMINIUM LOUVERED  
 A-ALLUMINIUM  
 PVC-PLASTIC  
 S.S- STAINLESS STEEL  
 FB-FIBER BOARD  
 F.G-FROST GLASS

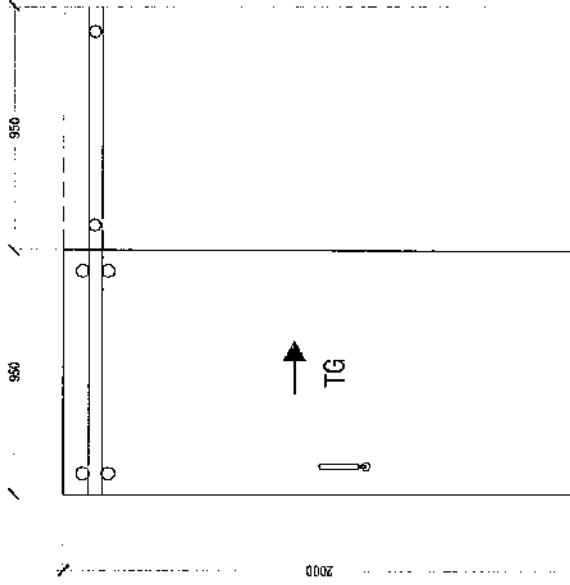

- GLASS DOOR PANEL
- DOOR HANDLE FINISHED IN BLACK POWDER COATED STAINLESS STEEL
- STAINLESS STEEL LOCK AND DOOR HANDLE

(SD1) SLIDING DOOR 1  
 SCALE 1:20

**MACO**  
 D E S I G N S  
 Contact: 7988866, 7891871  
 Email: info@maco.my

CLIENT:  
**JAUFAR RASHEED**  
 PROJECT:  
**LUCKYLAST**  
 AA, KULHAS

INTERIOR DESIGNER TEAM  
 NIKAJID  
 ASIF  
 FAYYAH  
 NILOOFAR

SCALE: AS GIVEN  
 DRAWING TITLE: AS GIVEN  
 DATE: 02/08/2021  
 REVISION NO: 00

REVISION NO: 00  
 PROJECT: LUCKYLAST  
 PRODUCTION: INTERIOR PROJECTS  
 P:\PROJECTS\LUCKYLAST





WARNING:  
 THIS DRAWING IS THE PROPERTY OF MACO DESIGN & CONSTRUCTION. IT IS TO BE USED ONLY FOR THE PROJECT AND SITE SPECIFICALLY MENTIONED HEREIN. IT IS NOT TO BE REPRODUCED, COPIED, OR TRANSMITTED IN ANY FORM OR BY ANY MEANS, ELECTRONIC OR MECHANICAL, INCLUDING PHOTOCOPYING, RECORDING, OR BY ANY INFORMATION STORAGE AND RETRIEVAL SYSTEM, WITHOUT THE WRITTEN PERMISSION OF MACO DESIGN & CONSTRUCTION.

**ID64**

RFFL



  - NOTE:  
T-TIMBER  
G-GLASS  
TG-TEMPERED GLASS  
TL-TIMBER LOUVERED  
GL-GLASS LOUVERED  
AL-ALUMINIUM LOUVERED  
A-ALLUMINIUM  
PVC-PLASTIC  
S.S- STAINLESS STEEL  
FB-FIBER BOARD  
F.G-FROST GLASS

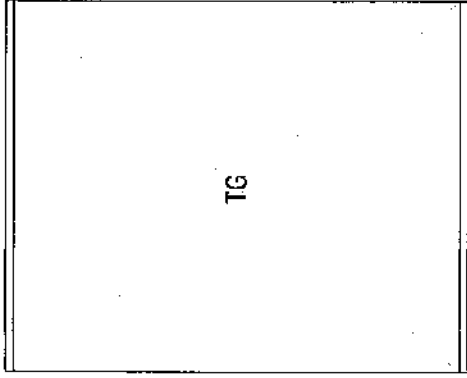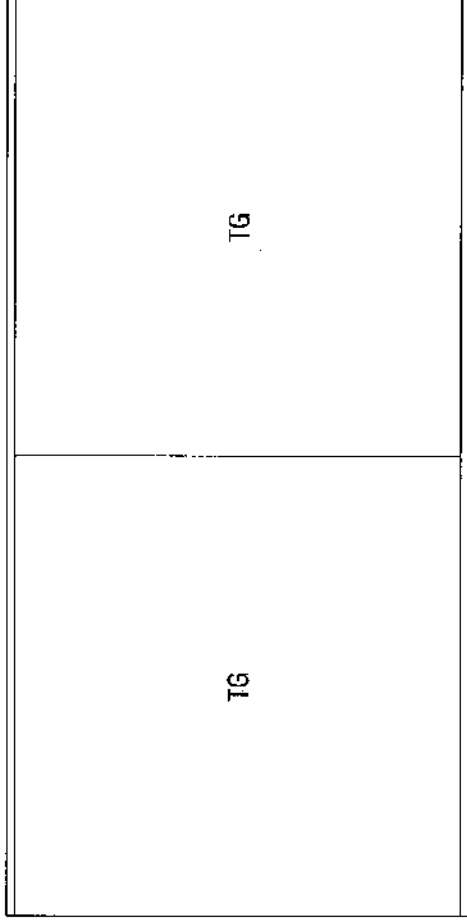

RFFL

- BLACK POWDER COATED WINDOW FRAME

**MACO**  
DESIGNS

Contact: 7689586, 7681671  
Email: info@macodesigns.com

CLIENT:  
JAUFAR RASHEED

PROJECT:  
LUCKYLAST

AA UKULHAS

INTERIOR DESIGN TEAM:  
NAAJID  
ASIF  
FAYYAZH  
NILOOFAR

SCALE: AS GIVEN


DRAWING TITLE : AS GIVEN

DATE: 02/20/2021

REVISION: 00

FILE NAME:  
C:\WORKING DRAWING\MACO PROJECTS\LUCKYLAST\ID66.DWG


WARNING:  
THIS DRAWING IS THE PROPERTY OF MACO DESIGNS. IT IS TO BE USED ONLY FOR THE PROJECT AND SITE SPECIFICALLY MENTIONED. IT IS NOT TO BE REPRODUCED, COPIED, OR TRANSMITTED IN ANY FORM OR BY ANY MEANS, ELECTRONIC OR MECHANICAL, WITHOUT THE WRITTEN PERMISSION OF MACO DESIGNS.

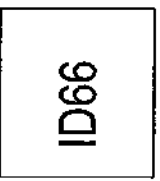

FG3 FIXED GLASS 3  
SCALE 1:20

FG4 FIXED GLASS 4  
SCALE 1:20

- NOTE;  
 T-TIMBER  
 G-GLASS  
 TG-TEMPERED GLASS  
 TL-TIMBER LOUVERED  
 GL-GLASS LOUVERED  
 AL-ALUMINIUM LOUVERED  
 A-ALLUMINIUM  
 PVC-PLASTIC  
 S.S- STAINLESS STEEL  
 FB-FIBER BOARD  
 F.G-FROST GLASS

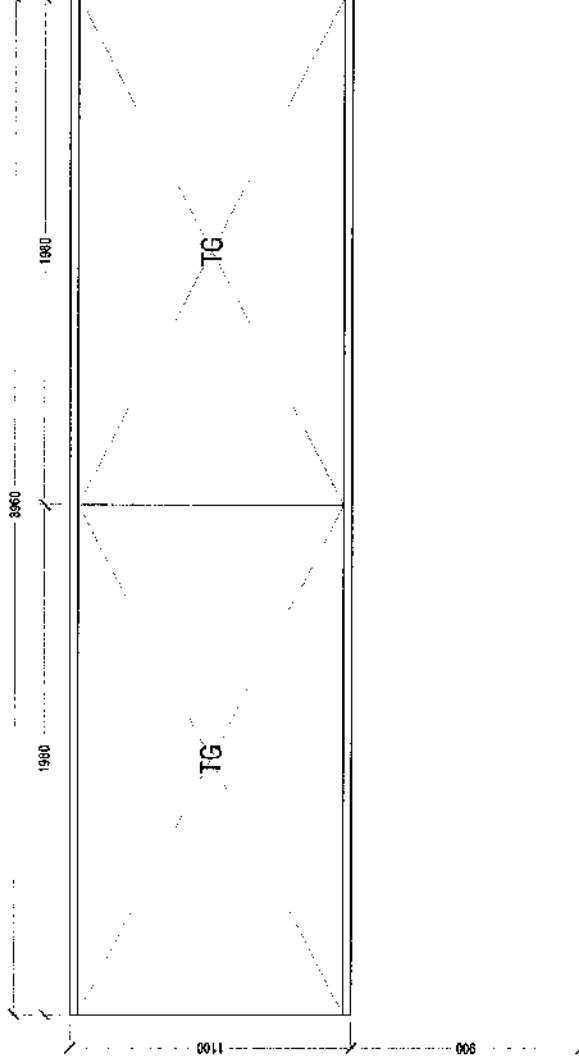

- BLACK POWDER COATED WINDOW FRAME

RFFL




Contact: 7899955, 7681671  
 Email: info@maco.my

CLIENT: JAUFAR RASHEED  
 PROJECT: LUCKYLAST  
 AAUKULHAS

INTERIOR DESIGNER TEAM  
 NANAJID  
 ASIF  
 FAYYAH  
 NILOOFAR


SCALE: AS GIVEN  
 DRAWING TITLE : AS GIVEN  
 DATE : 02/01/2021  
 REVISION NO.: 01  
 FILE NAME :  
 PROJECT NO.:  
 PROJECT LOCATION:  
 PROJECT DESCRIPTION:  
 PROJECT CONTACT:

WARNING:  
 THIS DRAWING IS THE PROPERTY OF MACO DESIGNS. IT IS TO BE USED ONLY FOR THE PROJECT AND LOCATION SPECIFIED HEREIN. ANY REPRODUCTION OR USE OF THIS DRAWING FOR ANY OTHER PROJECT OR LOCATION WITHOUT THE WRITTEN PERMISSION OF MACO DESIGNS IS STRICTLY PROHIBITED. ANY VIOLATION OF THIS WARNING WILL BE AT THE USER'S SOLE RISK AND LIABILITY.

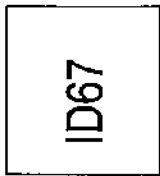

FG5 FIXED GLASS 5  
 SCALE 1:20

- NOTE:  
 T-TIMBER  
 G-GLASS  
 TG-TEMPERED GLASS  
 TL-TIMBER LOUVERED  
 GL-GLASS LOUVERED  
 AL-ALUMINIUM LOUVERED  
 A-ALLUMINIUM  
 PVC-PLASTIC  
 S.S- STAINLESS STEEL  
 FB-FIBER BOARD  
 F.G-FROST GLASS

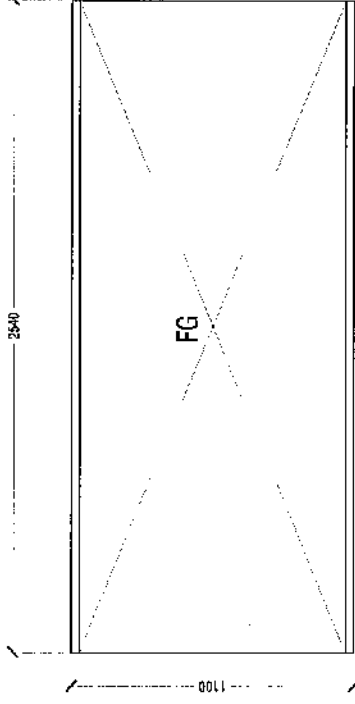

900

---

- BLACK POWDER COATED WINDOW FRAME

**MACO**  
 DESIGNS  
 Contact: 7989955, 7681671  
 Email: info@maco.my

CLIENT:  
 JAUFAR RASHEED

PROJECT:  
 LUCKYLAST  
 AAJUKULHAS

INTERIOR DESIGNER TEAM  
 MAAJID  
 ASIF  
 FAYYAH  
 RILOOPAR

SCALE: AS GIVEN  
 DRAWING TITLE: AS GIVEN  
 DATE: 20/11/2023

REVISION NO. 01  
 FILE NAME:  
 001-001-0000000000-000000  
 001-001-0000000000-000000  
 001-001-0000000000-000000


REMARKS:  
 1. ALL DIMENSIONS ARE IN METERS UNLESS SPECIFIED OTHERWISE.  
 2. ALL DIMENSIONS ARE TO FACE UNLESS SPECIFIED OTHERWISE.  
 3. ALL DIMENSIONS ARE TO FACE UNLESS SPECIFIED OTHERWISE.  
 4. ALL DIMENSIONS ARE TO FACE UNLESS SPECIFIED OTHERWISE.  
 5. ALL DIMENSIONS ARE TO FACE UNLESS SPECIFIED OTHERWISE.

ID68

FG6 FIXED GLASS 6  
 SCALE 1:20



- NOTE;
- T-TIMBER
  - G-GLASS
  - TG-TEMPERED GLASS
  - TL-TIMBER LOUVERED
  - GL-GLASS LOUVERED
  - AL-ALUMINIUM LOUVERED
  - A-ALLUMINIUM
  - PVC-PLASTIC
  - S.S- STAINLESS STEEL
  - FB-FIBER BOARD
  - F.G-FROST GLASS

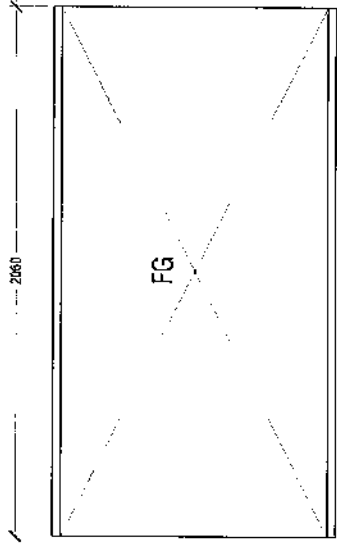

RFFL

- BLACK POWDER COATED WINDOW FRAME



Contact: 7698966, 7691671  
Email: info@macco.my

CLIENT:  
JAUFAR RASHEED

PROJECT:  
LUCKYLAST

AA.LUKULHAS

INTERIOR DESIGNER TEAM  
NAAJID  
ASIF  
FAYYAH  
NILDOPAR

SCALE: AS GIVEN

DRAWING TITLE: AS GIVEN

DATE: 03/01/2021

REVISION NO.: 04


PREPARED BY:  
DESIGNED BY:  
CHECKED BY:  
PROJECT MANAGER: PROJECTS  
APPROVED BY: DRAWING

WARNING:  
THIS DRAWING IS THE PROPERTY OF MACCO DESIGN S. IT IS TO BE USED ONLY FOR THE PROJECT AND SITE SPECIFICALLY MENTIONED HEREIN. IT IS NOT TO BE REPRODUCED, COPIED, OR TRANSMITTED IN ANY FORM OR BY ANY MEANS, ELECTRONIC OR MECHANICAL, INCLUDING PHOTOCOPYING, RECORDING, OR BY ANY INFORMATION STORAGE AND RETRIEVAL SYSTEM, WITHOUT THE WRITTEN PERMISSION OF MACCO DESIGN S.




FG8 FIXED GLASS 8  
SCALE 1:20

- NOTE
- SL = SLAB LINE
  - CL = CEILING LINE
  - DCL = DROP CEILING LINE
  - RFL = RAISED FLOOR FINISH LINE
  - FFL = FLOOR FINISH LINE

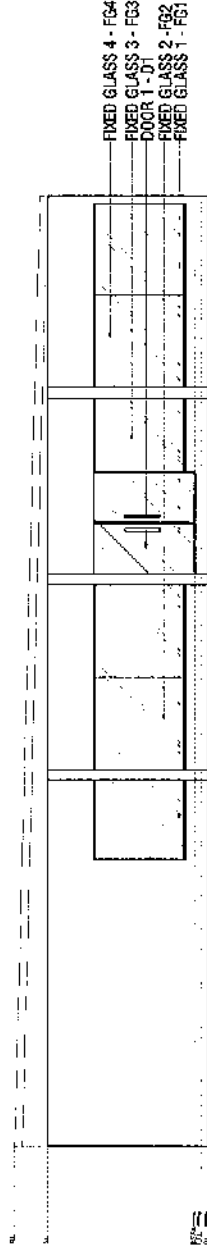

FRONT ELEVATION

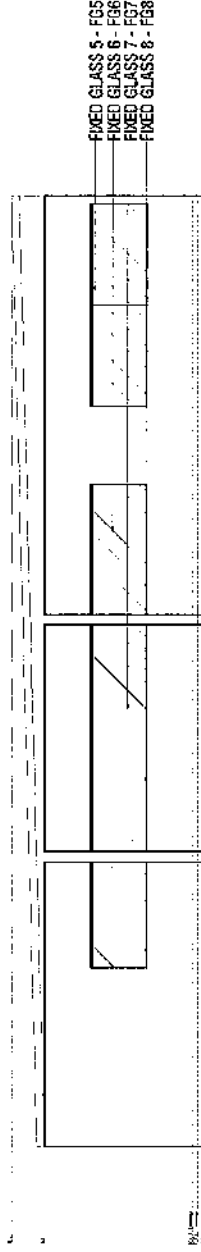

REAR ELEVATION

**MACO**  
DESIGNS

Contact: 7989866, 7691671  
Email: info@maco.mv

CLIENT:  
GURAIIDHOO COUNCIL

PROJECT:

GURAIIDHOO  
COUNCIL OFFICE

INTERIOR DESIGN TEAM

SHIFAU  
MAAJID  
ASIF  
KRYYYAH  
NILGOFAR

SCALE: AS SHOWN

DRAWING TITLE: AS SHOWN

DATE: 03/14/2022

REVISION NO.: 00

DESIGNED BY: SHIFAU MAAJID  
DRAWN BY: ASIF KRYYYAH  
CHECKED BY: NILGOFAR

DATE: 03/14/2022

PROJECT NO.: 2022-03-001  
DRAWING NO.: 2022-03-001-01  
SCALE: AS SHOWN








- NOTE
- ALL WALLS FINISHED IN MATT WHITE PAINT REF 5.03/4/1 UNLESS SPECIFIED OTHERWISE
  - WOOD SKIRTING FINISHED IN WHITE MATT PAINT REF 5.03 IN ALL AREAS






**EXTERIOR ELAVTION A & B**  
GURAIIDHOO COUNCIL OFFICE  
SCALE 1:100




ID71



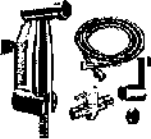


MATERIAL SCHEDULE					
NO.	NAME	COLOR	DESCRIPTION/	IMAGE	CODE
1	Light Grey Parquet Flooring	Grey	Wooden Parquet Flooring		5.01/F1
2	Rustic Slate Tiles	Grey & Brown(Multi)	300mm x 600mm		5.02/F2
3	Stone Wall Paper	White	Sherwin-Williams ALABASTER ( SW 7008)		5.03/W1
4	Wall paper- 1	Grey	Textured 3D effect Wall coverings		5.04/W2
5	Wall paper- 2	Brown (wood texture)	Textured 3D effect Wall coverings		5.05/W3
6	Terrazo tiles	Multi(beige)	300mm x 600mm		5.06/W4
7	Terrazo tiles	Multi (green)	300mm x 600mm		5.06/W5
8	Semi Gloss Green Paint	Gray Marble Pattern Floor Tiles	Water proof coating Sherwin-Williams Talipot Palm (SW 6726)		5.07

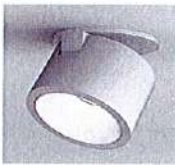9	Pine wood Laminate	Brown	Matte finish		5.08
10	White Laminate	White	Matte finish		5.09
11	Frosted glass	White/ Clear	etched sticker optional		5.1
12	Black powder coated metal	Black	Matte finish		5.11
13	Leather	Light grey	For all the cushions		5.12
14	Verticle blinds	White	Light filtering fabric		5.13
15	White marble counter top	White	Quartz Stone		5.14

<b>FIXTURE SCHEDULE</b>					
<b>NO.</b>	<b>NAME</b>	<b>COLOR</b>	<b>DESCRIPTION</b>	<b>IMAGE</b>	<b>CODE</b>
1	W/C	White Ceramic	Installation: Floor mounted Feature: Dual flush Drainage pattern: P trap, S trap Flushing method: Gravity flushing Toilet bowl shape: Round		2.01
2	Wash Basin	White Ceramic	Table Top Thin Rim Wash Basin 500 x 395 x 135 mm		2.02
3	Bidet	Stainless Steel	Stainless steel construction Includes wall mounted holder bracket Fitted with back-flow prevention device		2.03
4	Toilet Paper Roll	Stainless Steel	Installation type: Wall mounted		2.04
5	Faucet	Stainless Steel	Contemporary wall mounted design		2.05

LIGHTING SCHEDULE					
NO.	NAME	COLOR	DESCRIPTION	IMAGE	CODE
1	Ceiling Recessed Down Light	Matte White Painted Metal Fitting	Fixed downlight Diameter 10 cm, hole cutout size 9.2 cm, recess depth 17cm Bulb: 1 x 6 watt max LED GU10 (not included) Dimmable with dimmable bulb and suitable dimmer switch		3.01
2	LED Spot Lights	Matte White Painted Metal Fitting	Tubular shape Diameter: 90mm Height: 95 mm Surface mounted spot light 5 - 10 Watts		3.02
3	Suspended Light 1	Metal Fitting	LED office pendant lamp 1400 x 61 mm - Height:56mm		3.03
4	Suspended Light 2	Black powder coated aluminum	LED pendant lamps Rectangle 1820 x 1190 mm		3.04
5	Suspended Light 3	Black painted aluminum	LED pendant lamps Hexagon Diameter :1200 mm		3.05
6	LED strip ceiling light	Lighting color: Cool daylight	MasterConnect LEDtube IA 1500mm UO 25W865T8 Color Code 865 [ CCT of 6500K] Beam Angle (Nom) 160 ° Luminous Flux (Nom) 3700 l		3.06
7	LED Strip Light	Lighting color: Warm white	Power type: Plug in Length: 5 m Color specification: Dimming		3.07

FURNITURE SCHEDULE					
NO.	NAME	COLOR	DESCRIPTION	IMAGE	CODE
1	Office Chair 1	Black	Color: Black Material: Polyurethane Item Dimensions LxWxH: 20.5 x 20.9 x 43.3 inches Maximum Weight Recommendation: 285 Pounds Item Weight: 20 Pounds		4.01
2	Office Chair 2	Black	Upholstery Available In Fabric or Leather Available C.O.M. / C.O.L. Required Fabric For Upholstery: 1.79Lm / 5.87 ft Required Leather For Upholstery: 2.60 Sq m / 27.99 ft <sup>2</sup> Gross Weight: 26,20 Kg / 57.76 lb Volume: 0.35 Cbm / 12.36 ft <sup>3</sup> Box Dimensions: w 750 x d 710 x h 460/950 / 29.53" x 27.95" x 18.11/37.40"		4.02
3	Meeting table	Wood and black	dimensions L- 2100mm, W- 1200mm, H- 750mm Materials: Table top- Pine Wood Laminate Legs- Powder coated black metal		4.03

MACO  
DESIGNS





**MACO**  
DESIGNS



**AMACO**  
DESIGNS





**MACO**  
DESIGNS




**MAACO**  
DESIGNS



**AAACO**  
DESIGNS



**AMACO**  
DESIGNS

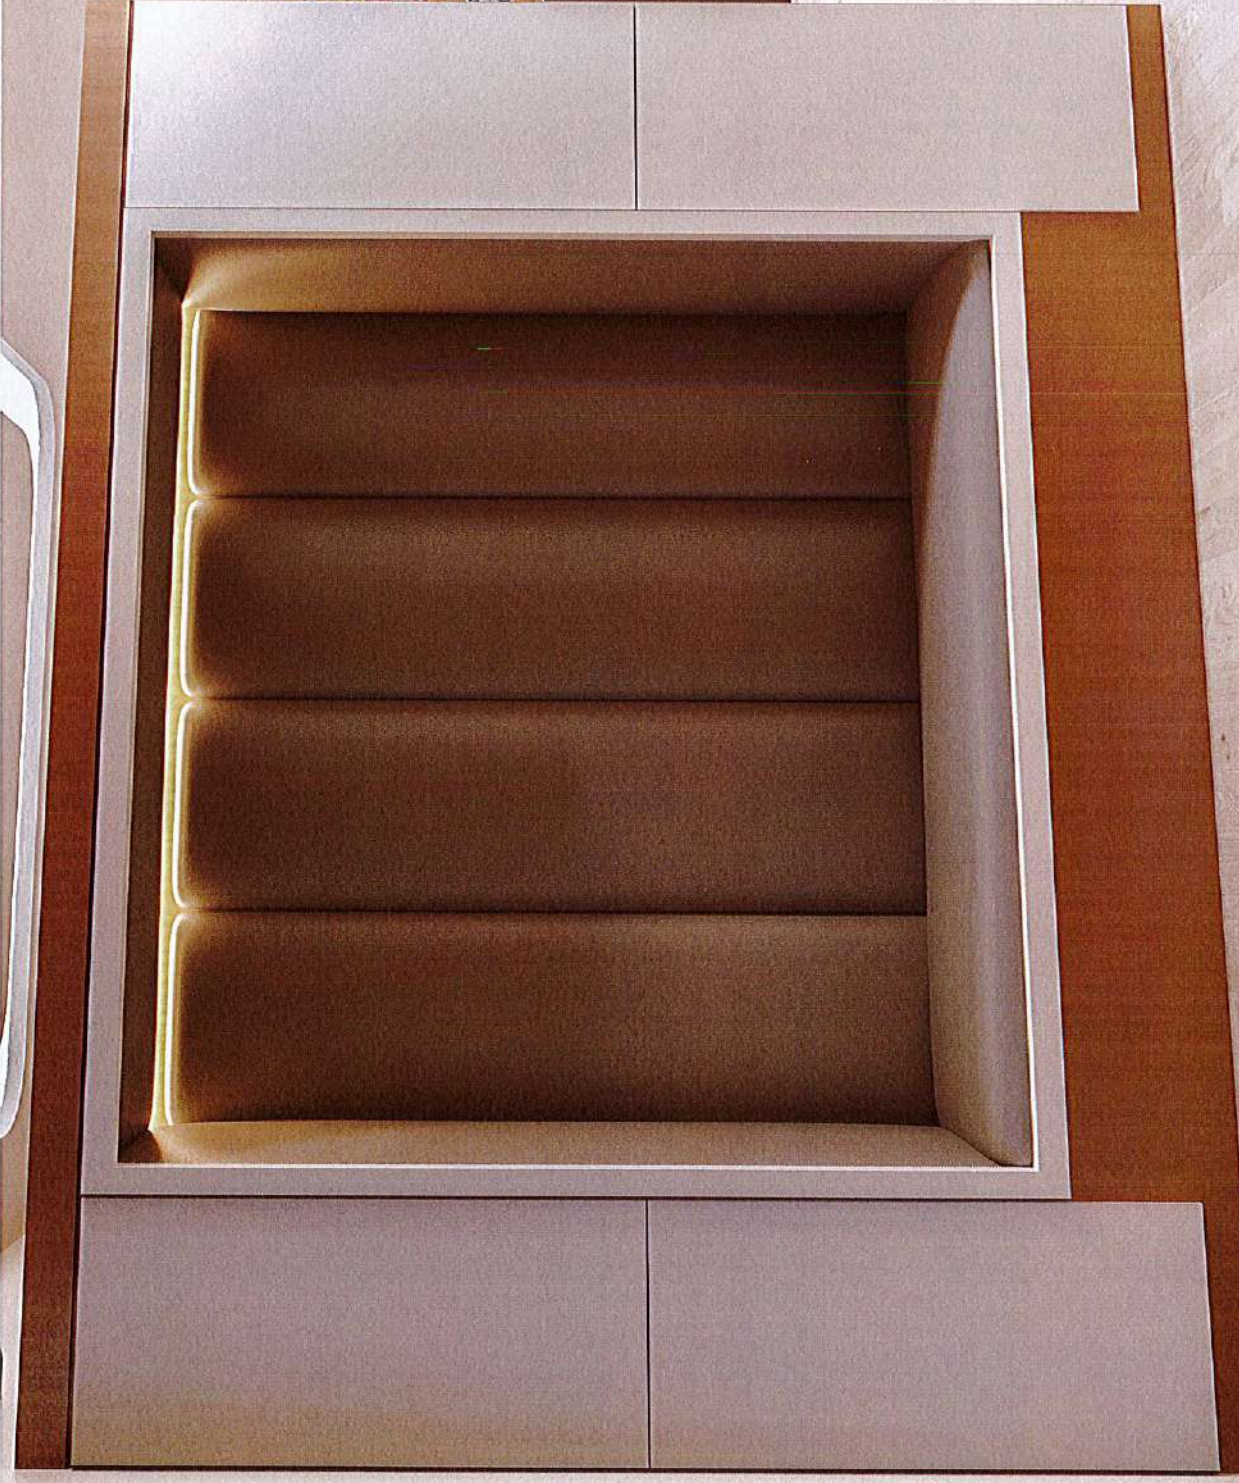





AAACO  
DESIGNS



**MAACO**  
DESIGNS





