




REFLECTED CEILING PLAN
SCALE: 1:100

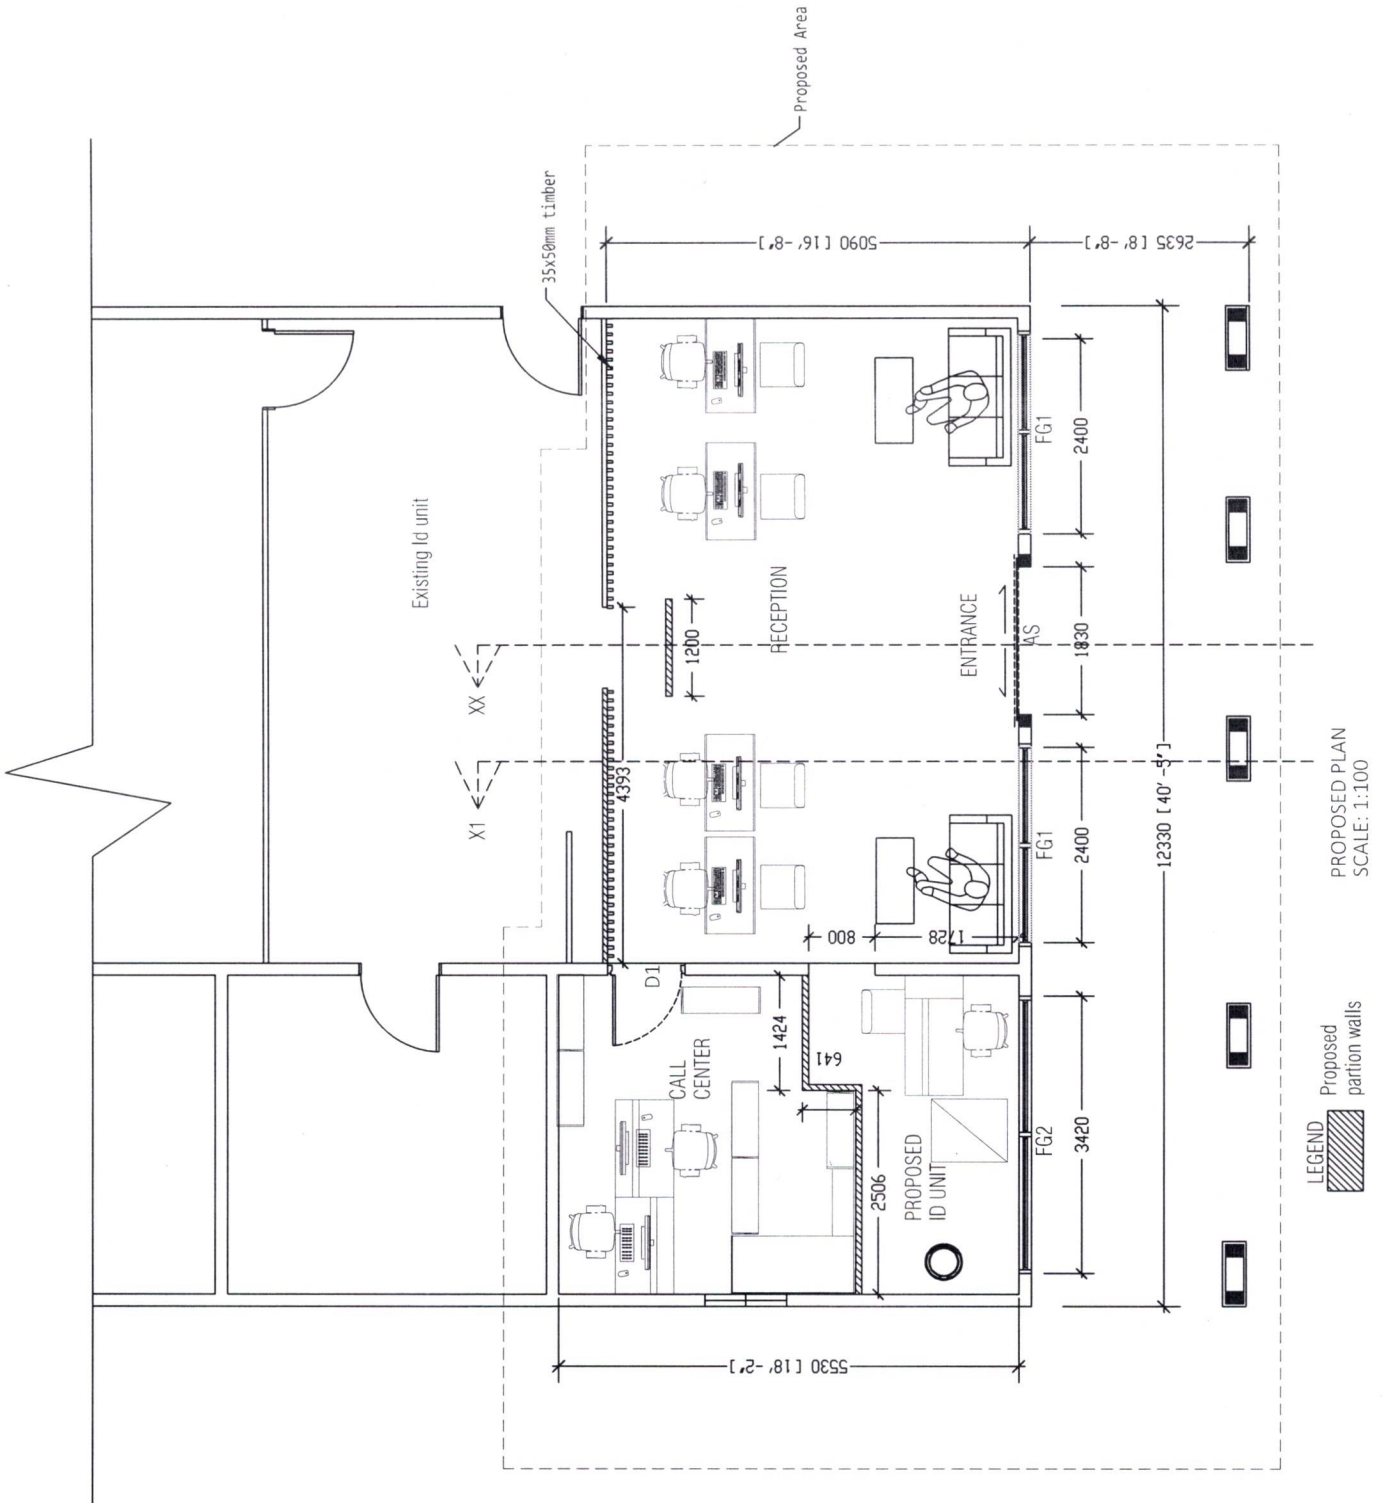


<p>NOTES:</p> <p>ALL THE OUT DOOR LIGHTS SHIF(T) BY 10% RATING</p> <p>ALL THE LIGHTS OR SPECS ARE REQUIRES APPROVAL</p>	<p>LED STRIP LIGHT WARM WHITE</p>	1 NOS
	<p>LED SPOT LIGHT WARM WHITE 40W</p>	8 NOS
	<p>LED SQUARE 300x300 PANEL LIGHT 18W</p>	16 NOS
	<p>RECTANGULAR 1200x300x25 (mm)</p>	8 NOS
	<p>LED SQUARE DOWNLIGHT DOWN LIGHT 48W</p>	6 NOS
	<p>SPOT LIGHT WARM WHITE 30W</p>	22 NOS
	<p>MINI LED UP DOWN WALL LIGHT 24W</p>	7 NOS
	<p>EMERGENCY LIGHT</p>	1 NOS

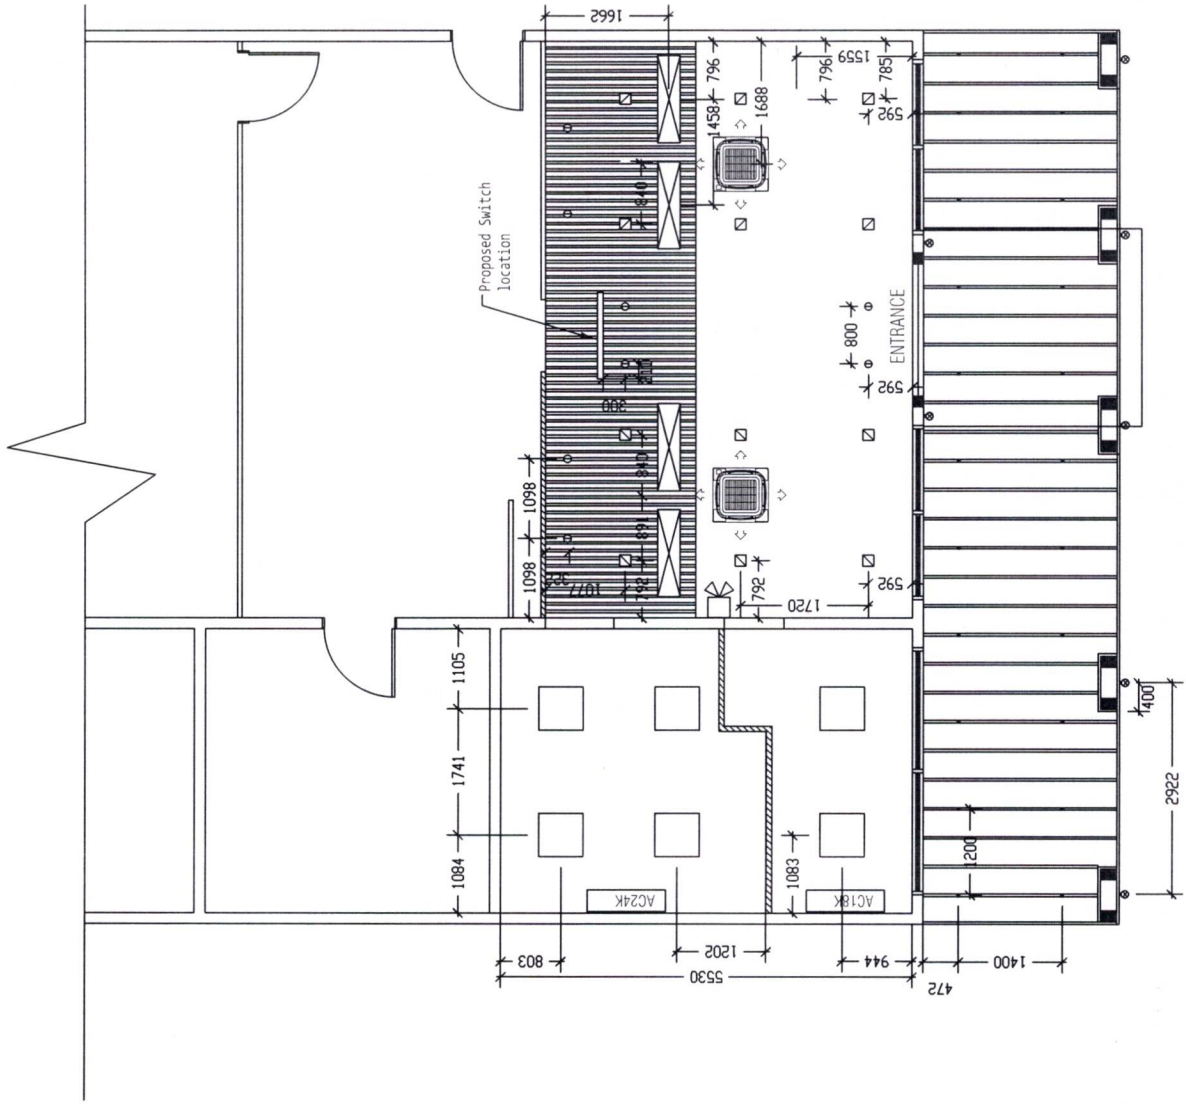


LIGHTING PLAN
SCALE: 1:100

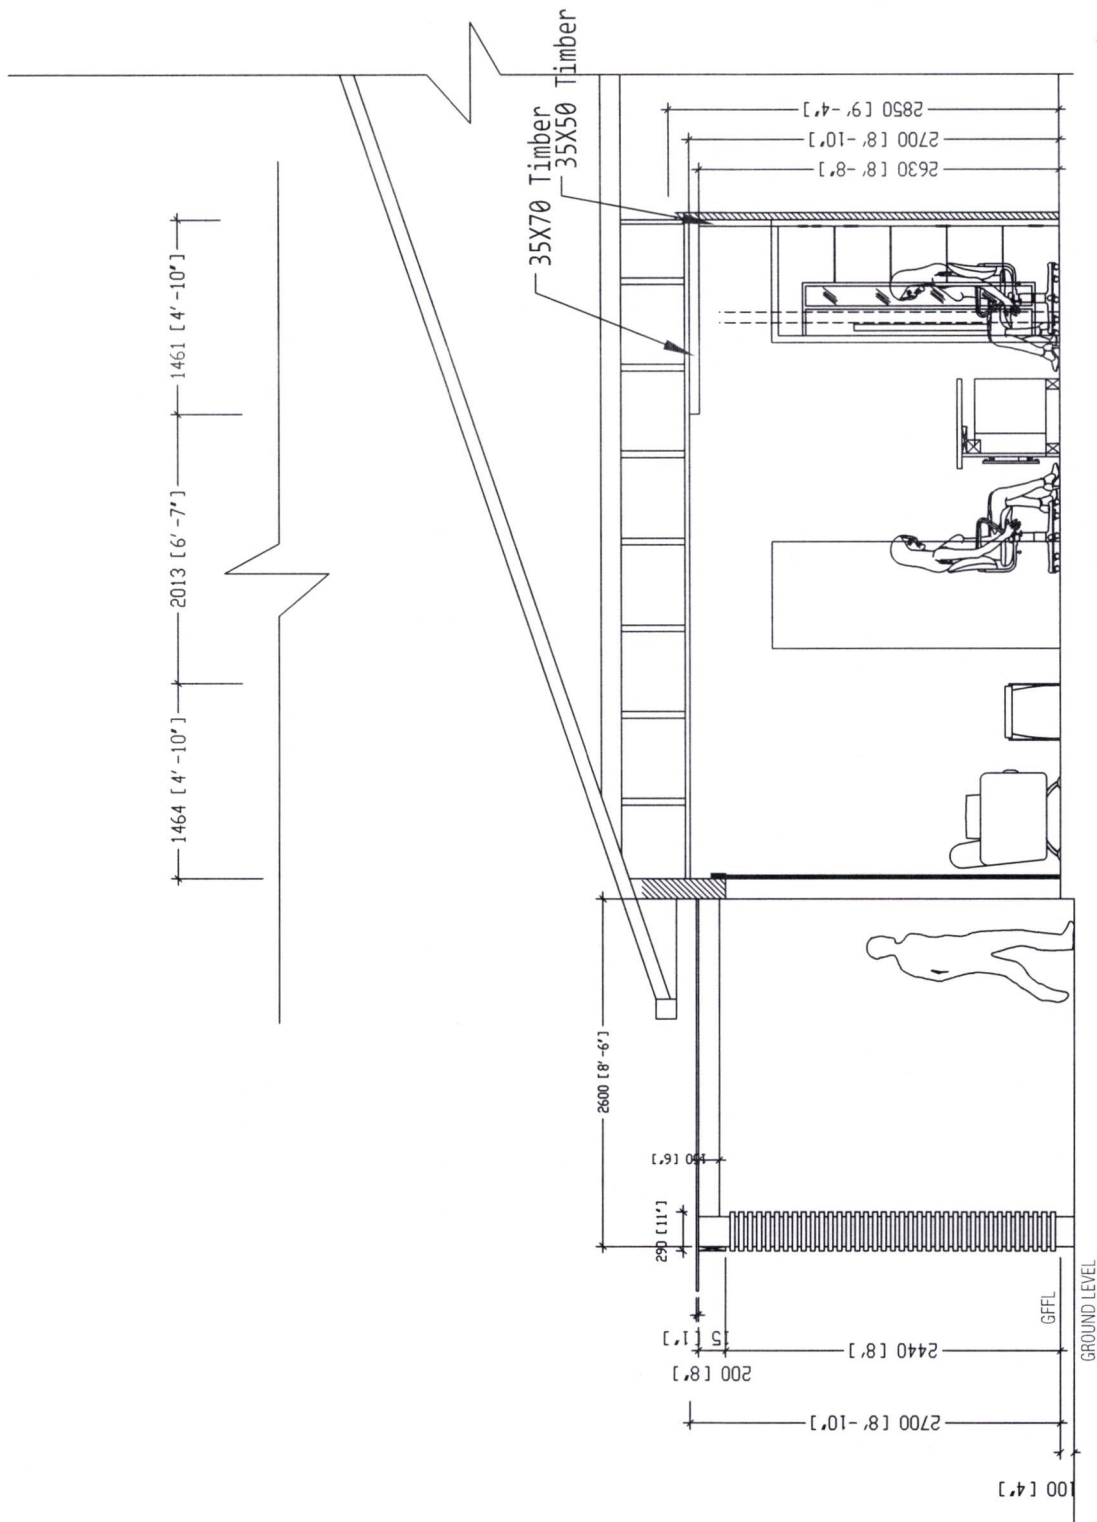

SECTIONXX
SCALE: 1:50

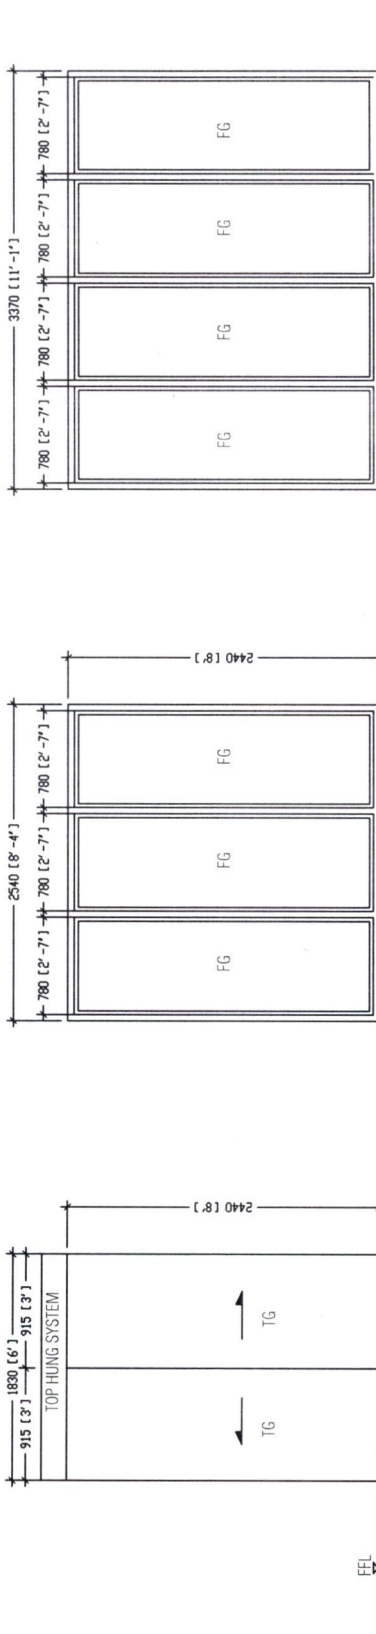

Door / QTY:	AS 01	FG 02	FG 01
Frame:	FRAMELESS	WHITE POWDERCOATED ALUMINIUM	WHITE POWDERCOATED ALUMINIUM
Leaf:	12MM TEMPERED GLASS	-	-
Glazing:	-	8MM CLEAR GLASS	8MM CLEAR GLASS
Ironmongery:	AUTOMATIC SYSTEM, SENSORS AND TRACKS AND OTHERS AS REQUIRED BY THE DOOR MANUFACTURER	LOCKS, DOOR HANDLE, DOOR CLOSER, KICK PLATES, HINGES WHERE REQUIRED AND AS INSTRUCTED CONSULTANT	LOCKS, DOOR HANDLE, DOOR CLOSER, KICK PLATES, HINGES WHERE REQUIRED AND AS INSTRUCTED CONSULTANT
Remarks:	SPECS BY MANUFACTURER AND APPROVED BY CONSULTANT ALSO PROVIDE ALLOWANCE FOR DOOR LOCK SYSTEM	-	-

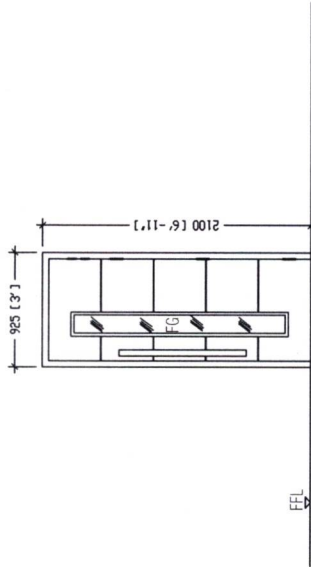


Door / QTY:	01
Frame:	SOLID TIMBER (WITH WOOD STAIN)
Leaf:	SOLID TIMBER (WITH WOOD STAIN)
Glazing:	8MM CLEAR GLASS
Ironmongery:	LOCKS, DOOR HANDLE, DOOR CLOSER, KICK PLATES, HINGES WHERE REQUIRED AND AS INSTRUCTED CONSULTANT
Remarks:	

NOTE

- ALL MEASUREMENTS TO BE CHECKED ON SITE BEFORE FABRICATION.
- PROVIDE RC LINTEL ABOVE ALL DOOR AND WINDOW UNITS NOT FIXED TO BEAMS.
- SHOP DRAWINGS ARE TO BE PROVIDED BY MANUFACTURER BEFORE FABRICATION
- ALL MATERIAL SPECS ARE TO BE PROVIDED BY THE MANUFACTURER AND APPROVED BY ARCHITECT BEFORE FABRICATION
- PROPER FIXING OPTIONS ARE TO BE PROVIDED BY THE MANUFACTURER AND APPROVED BY THE ARCHITECT


DOORS & WINDOWS
SCALE: 1:50

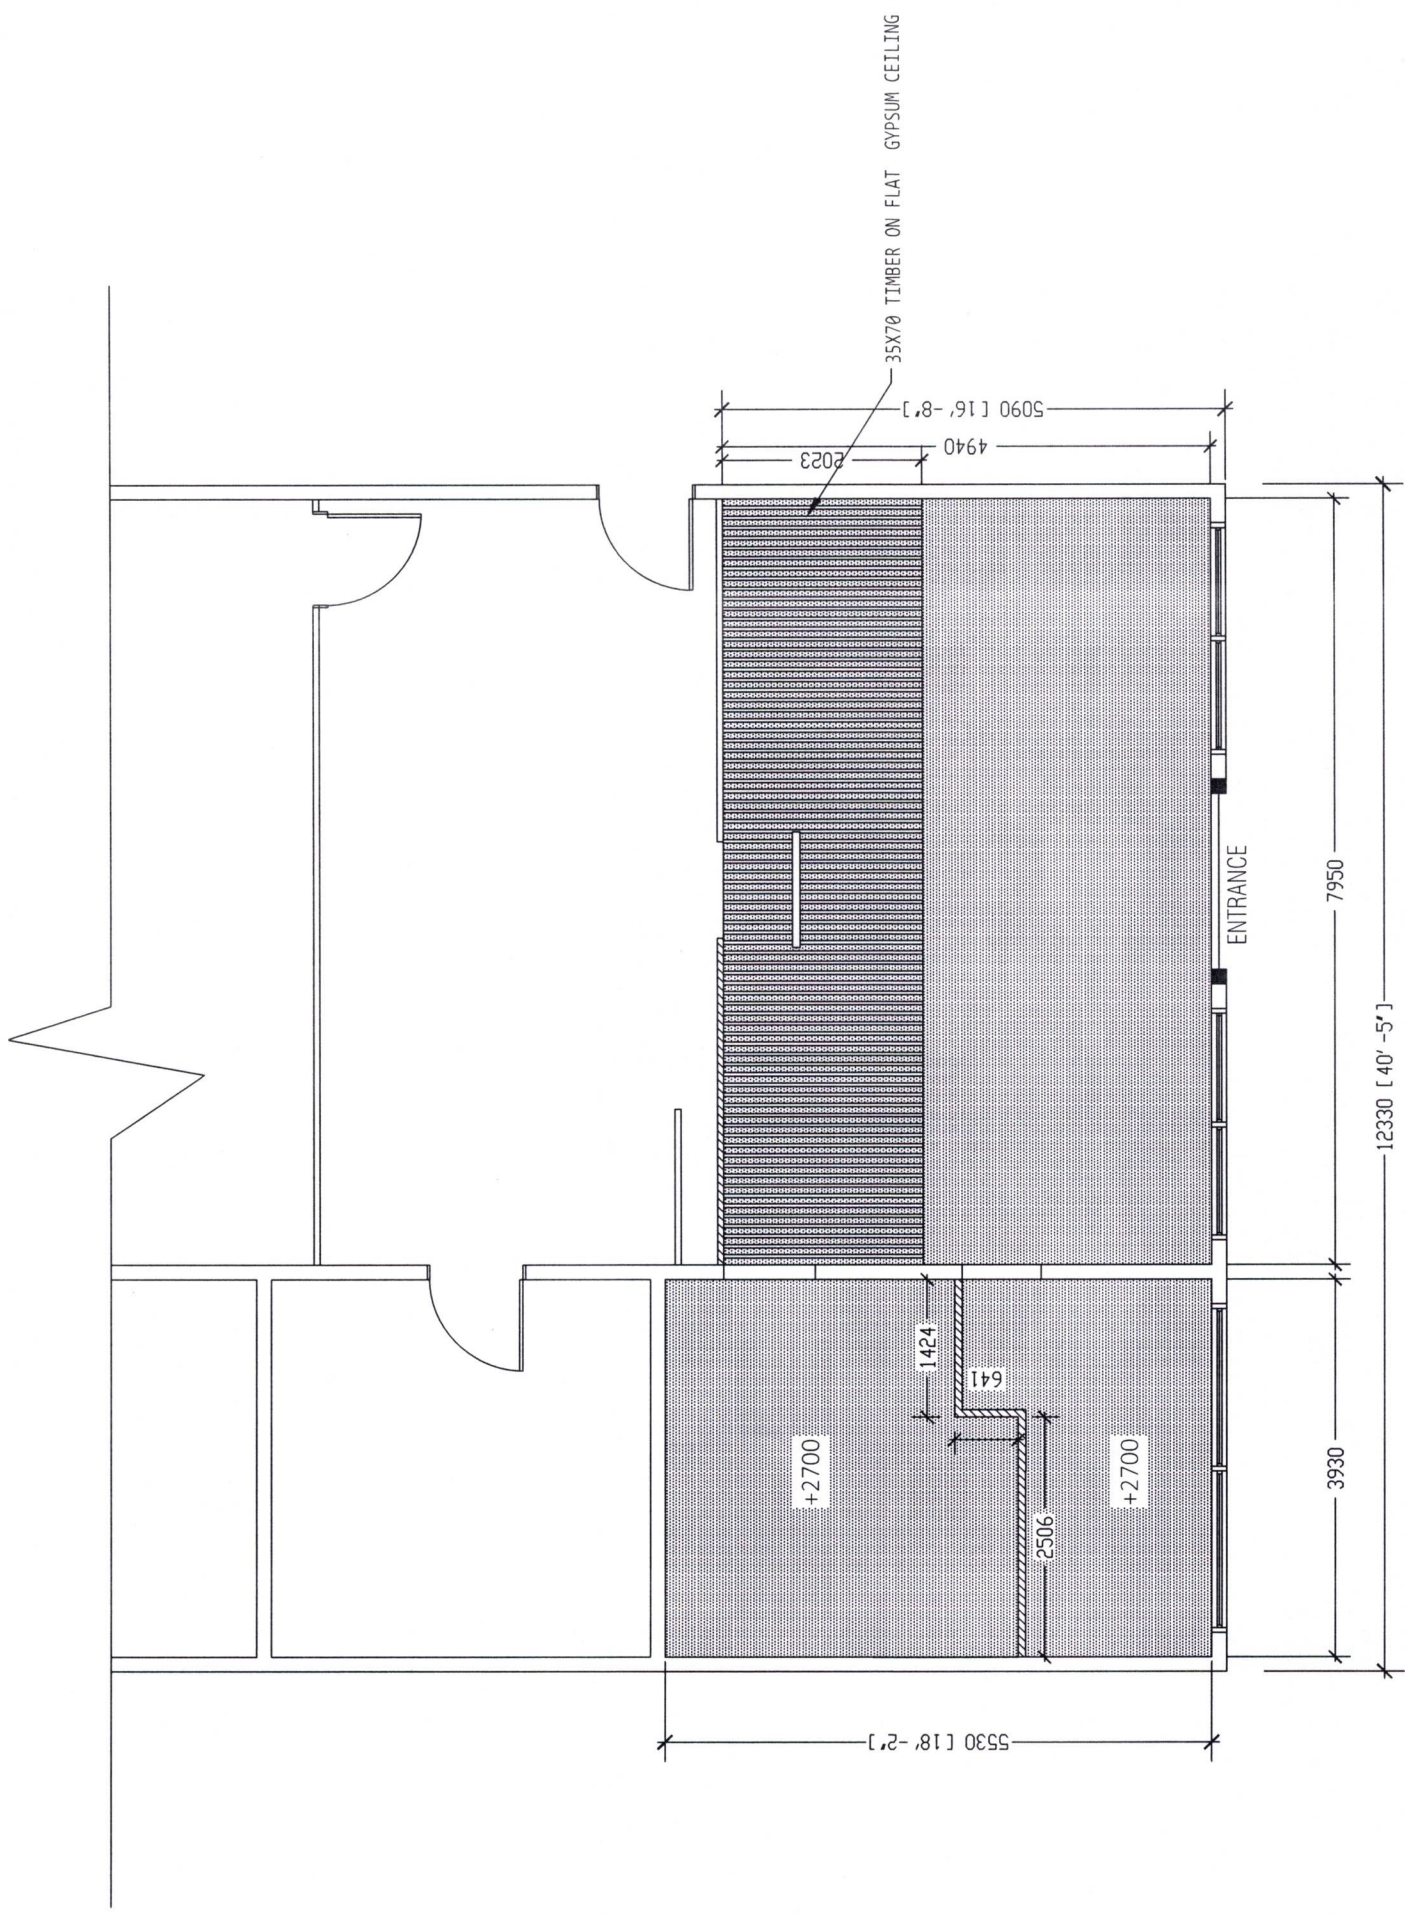


REFLECTED CEILING PLAN
SCALE: 1:100

WORKING DESK POWER POINTS
 AT 400MM FROM FFL FIXED TO DESK OR TO WALL WHERE DESK IS ADJACENT TO WALL
 WHERE DESKS ARE NOT ADJACENT TO WALL, WALL AND FLOOR CUTTING IS REQUIRED
 FOR WIRING
 PROVIDE ALLOWANCE FOR LOCK SYSTEM, AND CEILING CASSETTE, TYPE 2 AC UNITS


- 22 NOS 2x13A SOCKET OUTLET
- 01 NOS 1x13A SOCKET OUTLET
- 01 NOS WEATHER PROOF 2x13A SOCKET OUTLET (1P6S)
- 02 NOS 1x15A SOCKET OUTLET (2500mm ABOVE FFL)
- 01 NOS DISTRIBUTION BOARD

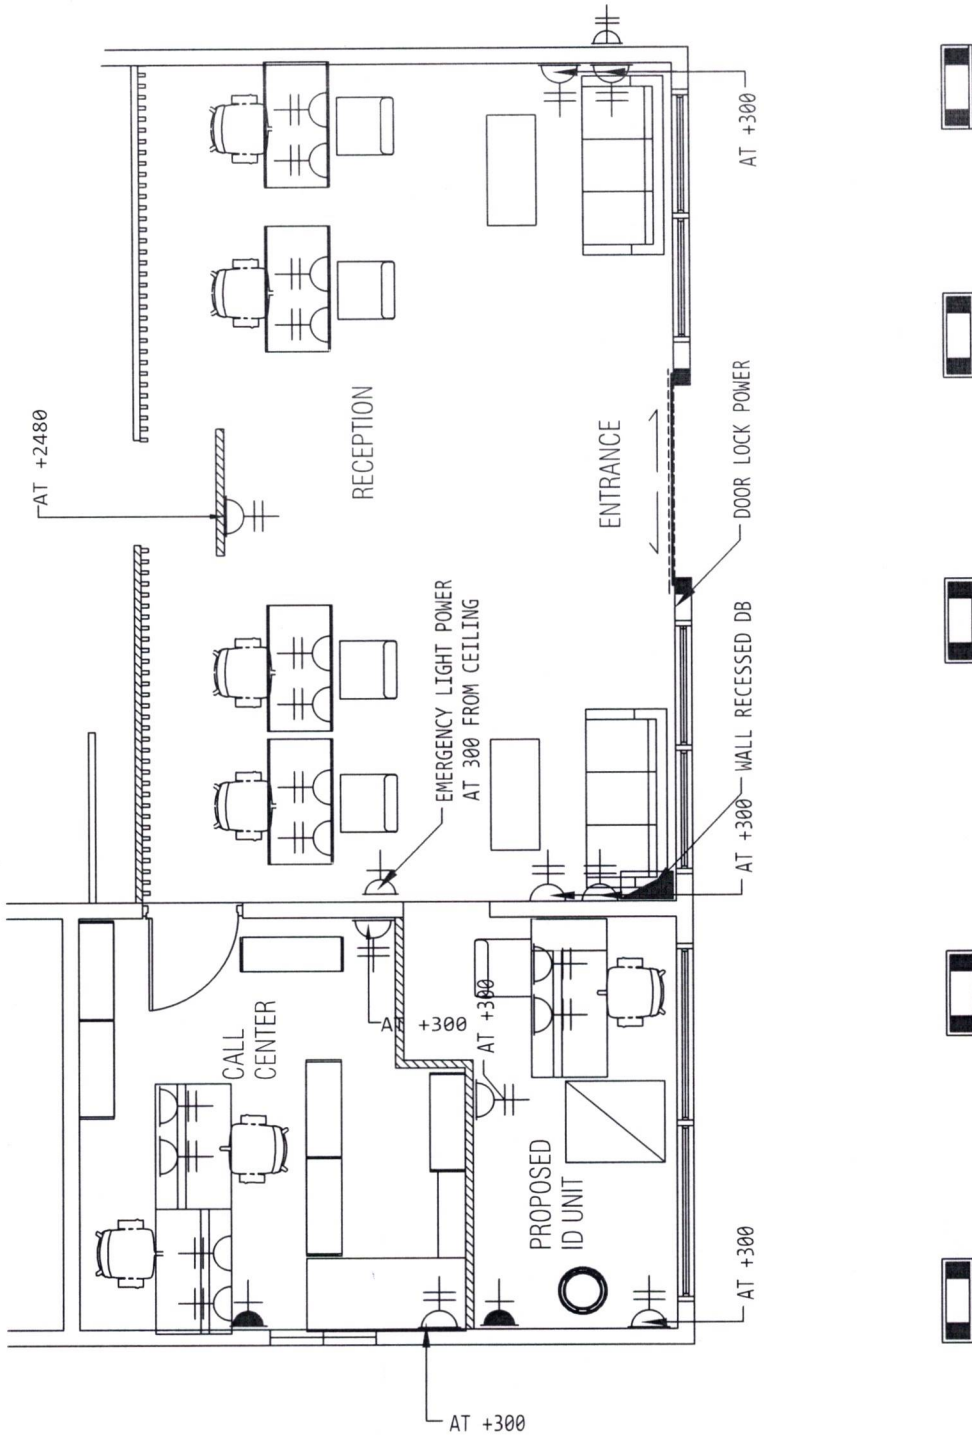

ELECTRICAL PLAN
 SCALE: 1:100

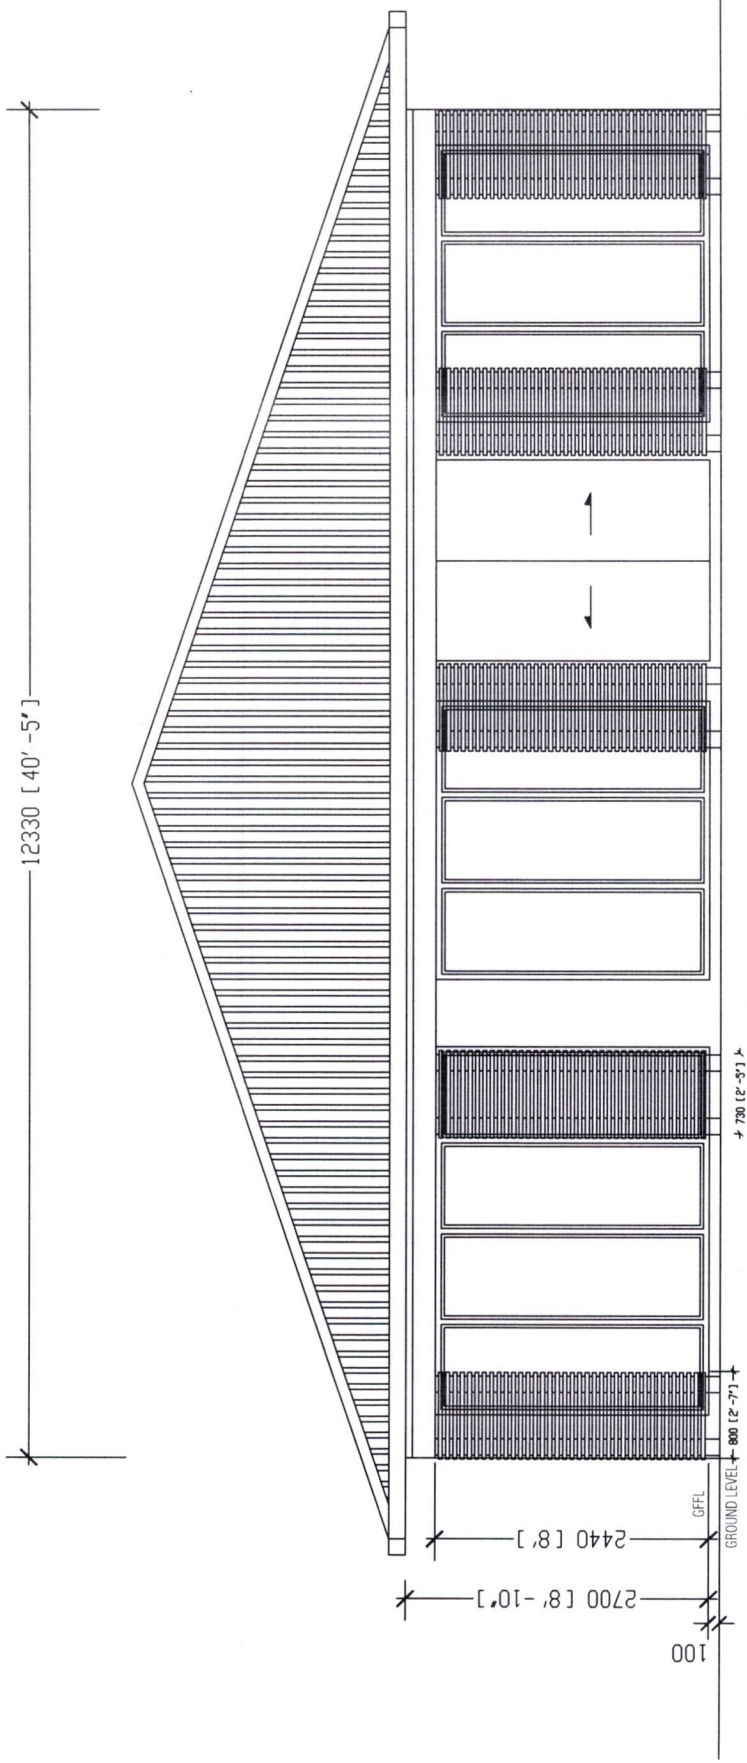

FRONT ELEVATION
SCALE: 1:100

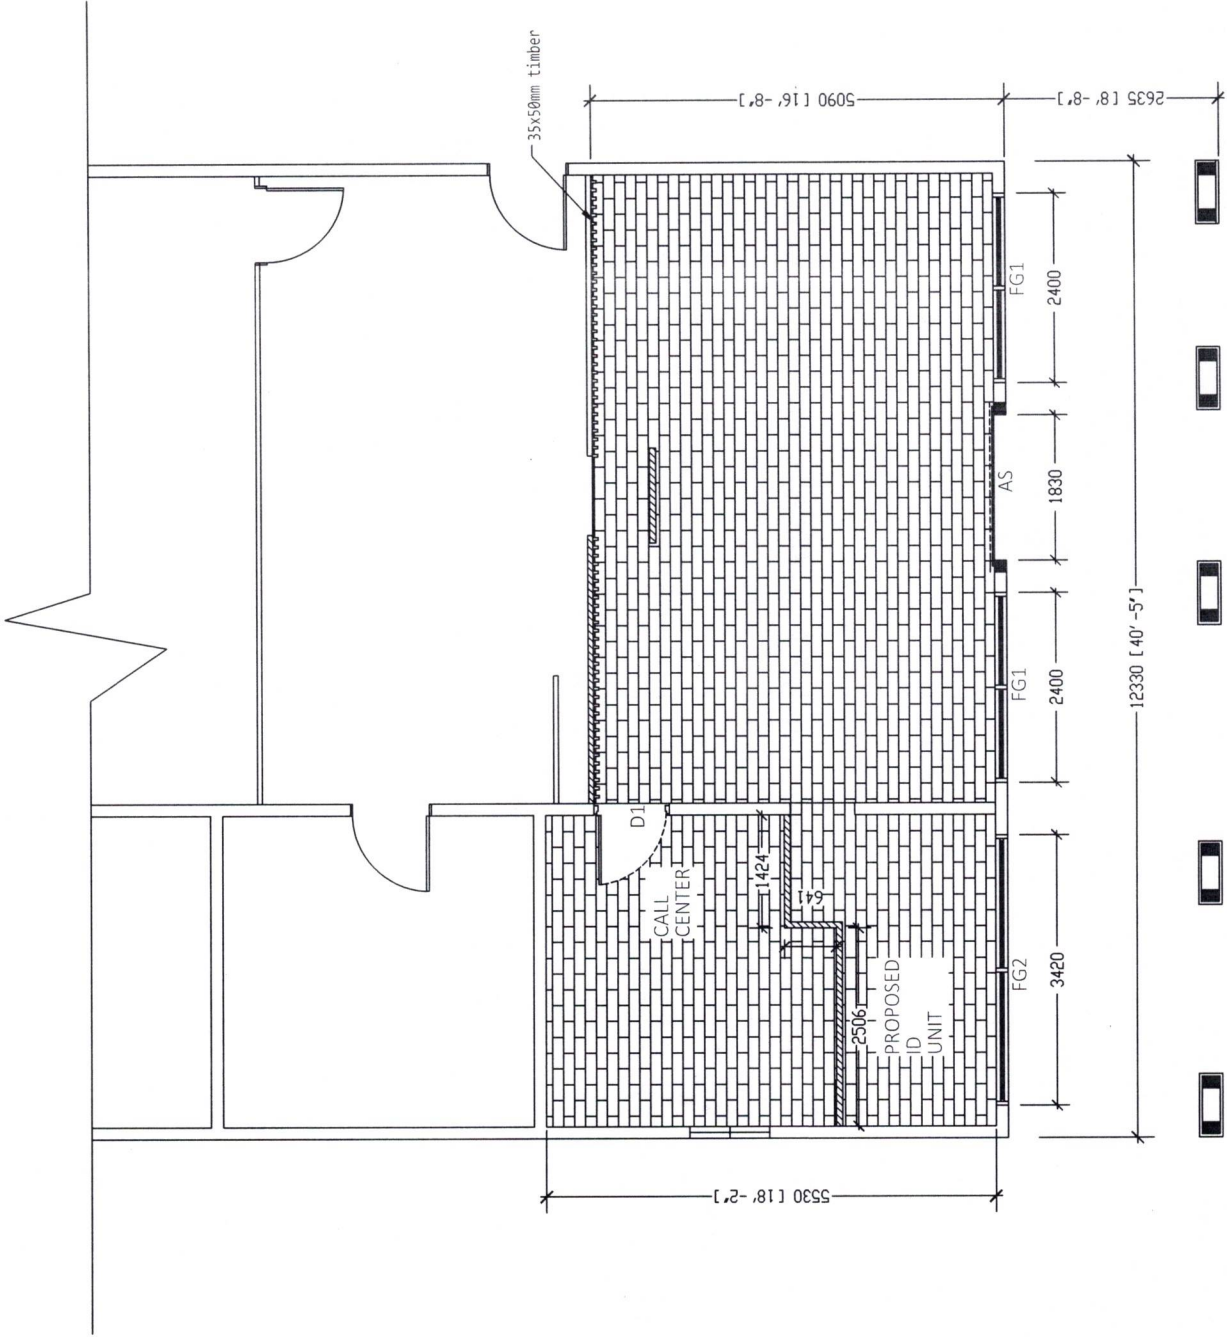


LEGEND


Tarkett
Flooring
laminated
62M2




FLOOR FINISH PLAN
SCALE: 1:100

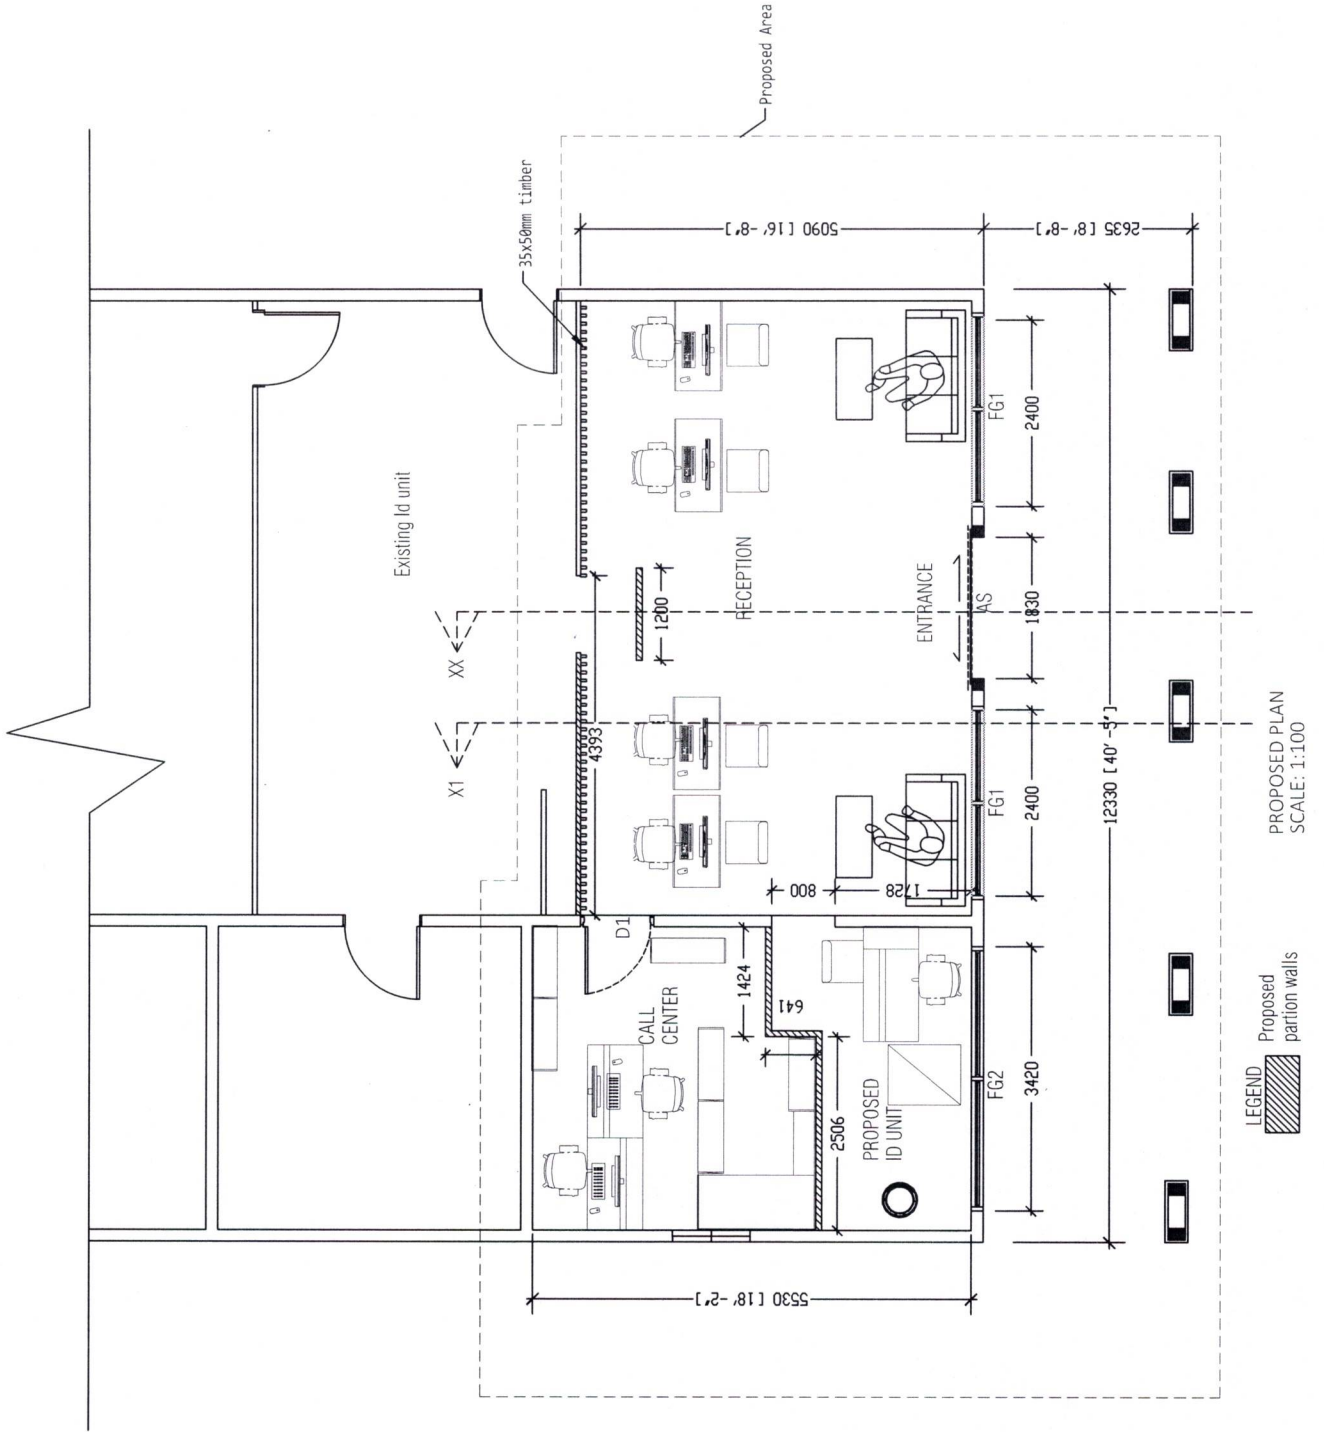

150 [6']

 


220 [9']

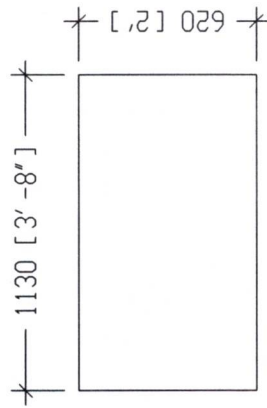

COLUMN DETAILS



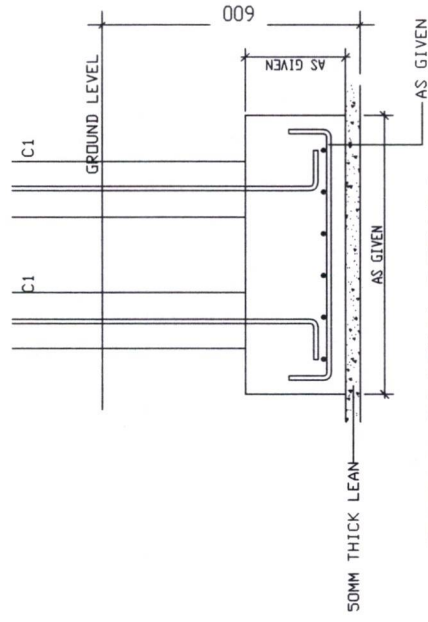





FOOTING DETAILS




TYPICAL FOOTING DETAILS


SCALE 1:20

FOUNDATION FOOTING DIMENSION	FOUNDATION FOOTING REIN
FOUNDATION FOOTING DETAILS	FOUNDATION FOOTING REIN
F1	T10@100MM C/C BW (B)


<p>NOTES:</p> <p>ALL THE OUT DOOR LIGHTS SHELLS OF THIS DRAWING ALL THE LIGHTS OF SPECS ARE REQUIRES APPROVAL</p>	 <p>LED STRIP LIGHT WARM WHITE</p>	1 NOS
	 <p>LED SPOT LIGHT WARM WHITE</p>	8 NOS
	 <p>LED SQUARE DOWN WALL LIGHT</p>	16 NOS
	 <p>RECTANGULAR LED DOWN WALL LIGHT</p>	8 NOS
	 <p>LED SQUARE DOWN WALL LIGHT</p>	6 NOS
	 <p>SPOT LIGHT WARM WHITE</p>	22 NOS
	 <p>METAL LED UP DOWN WALL LIGHT</p>	7 NOS
	 <p>EMERGENCY LIGHT</p>	1 NOS

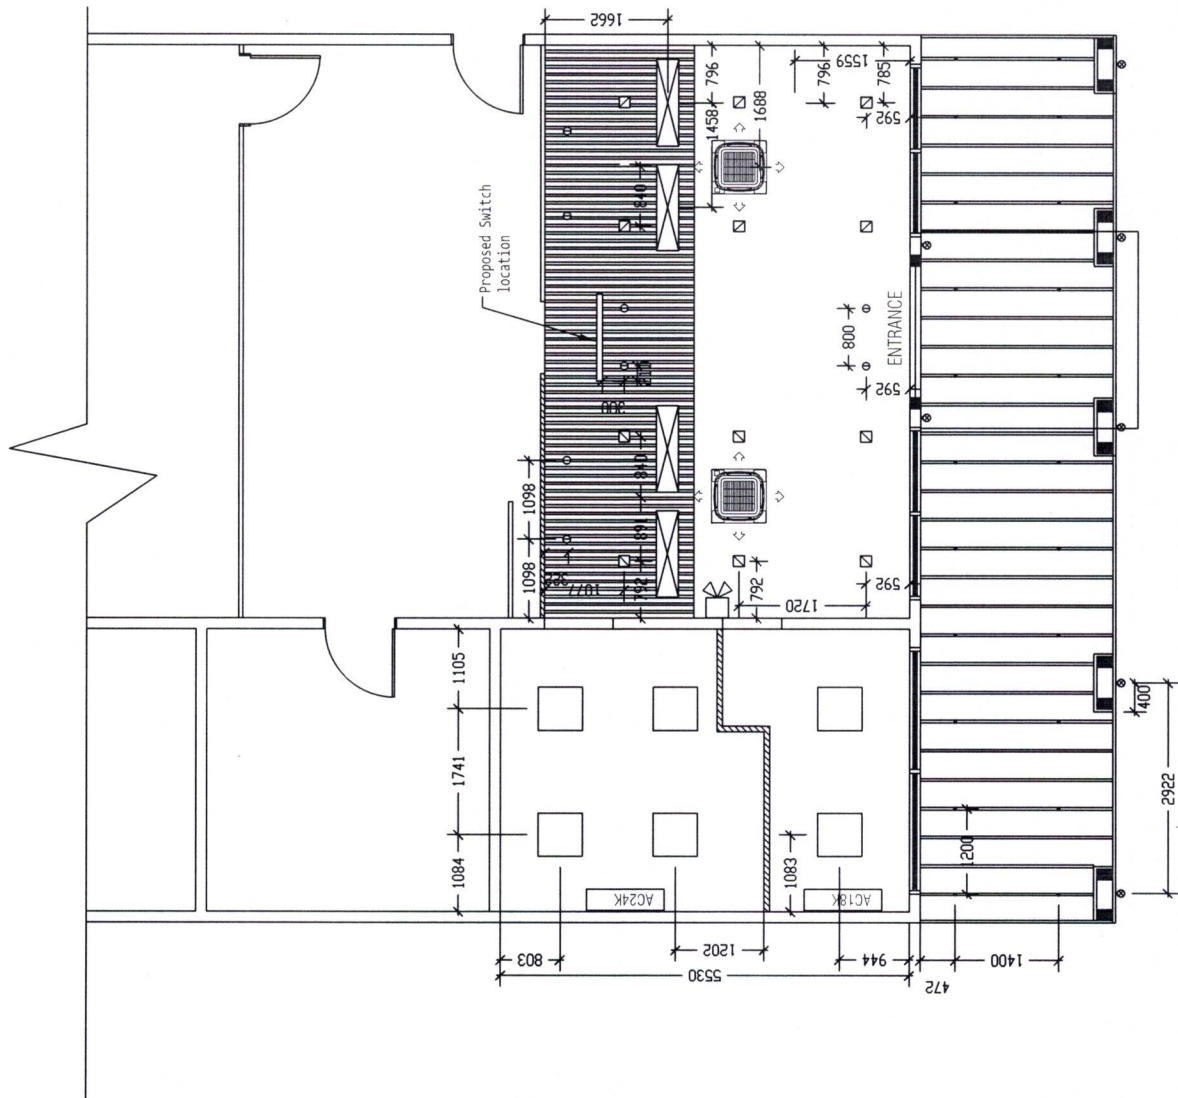


LIGHTING PLAN
SCALE: 1:100

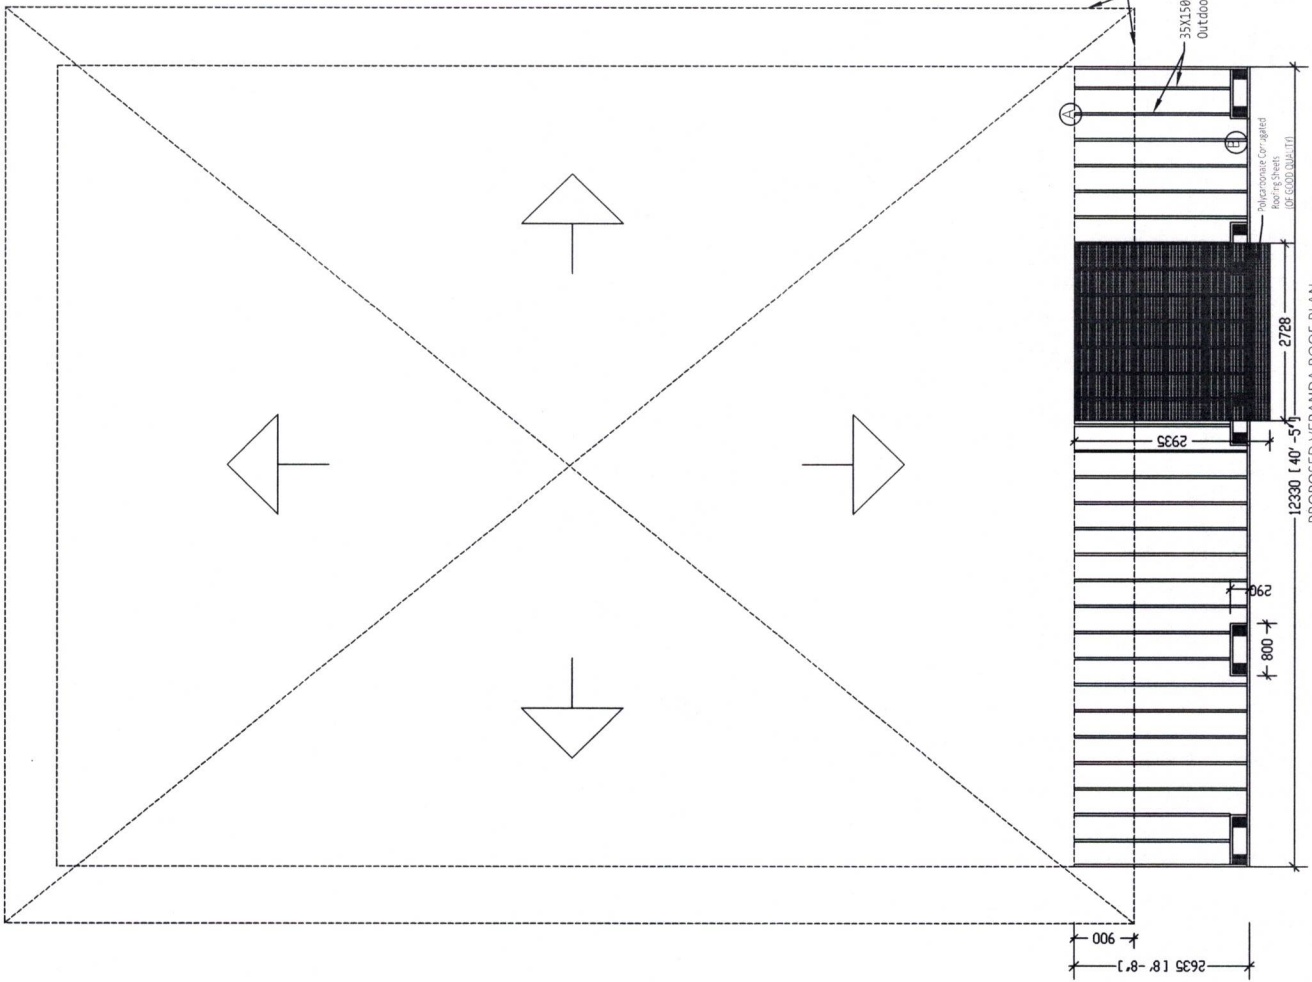


PROPOSED VERANDA ROOF PLAN
SCALE: 1:100

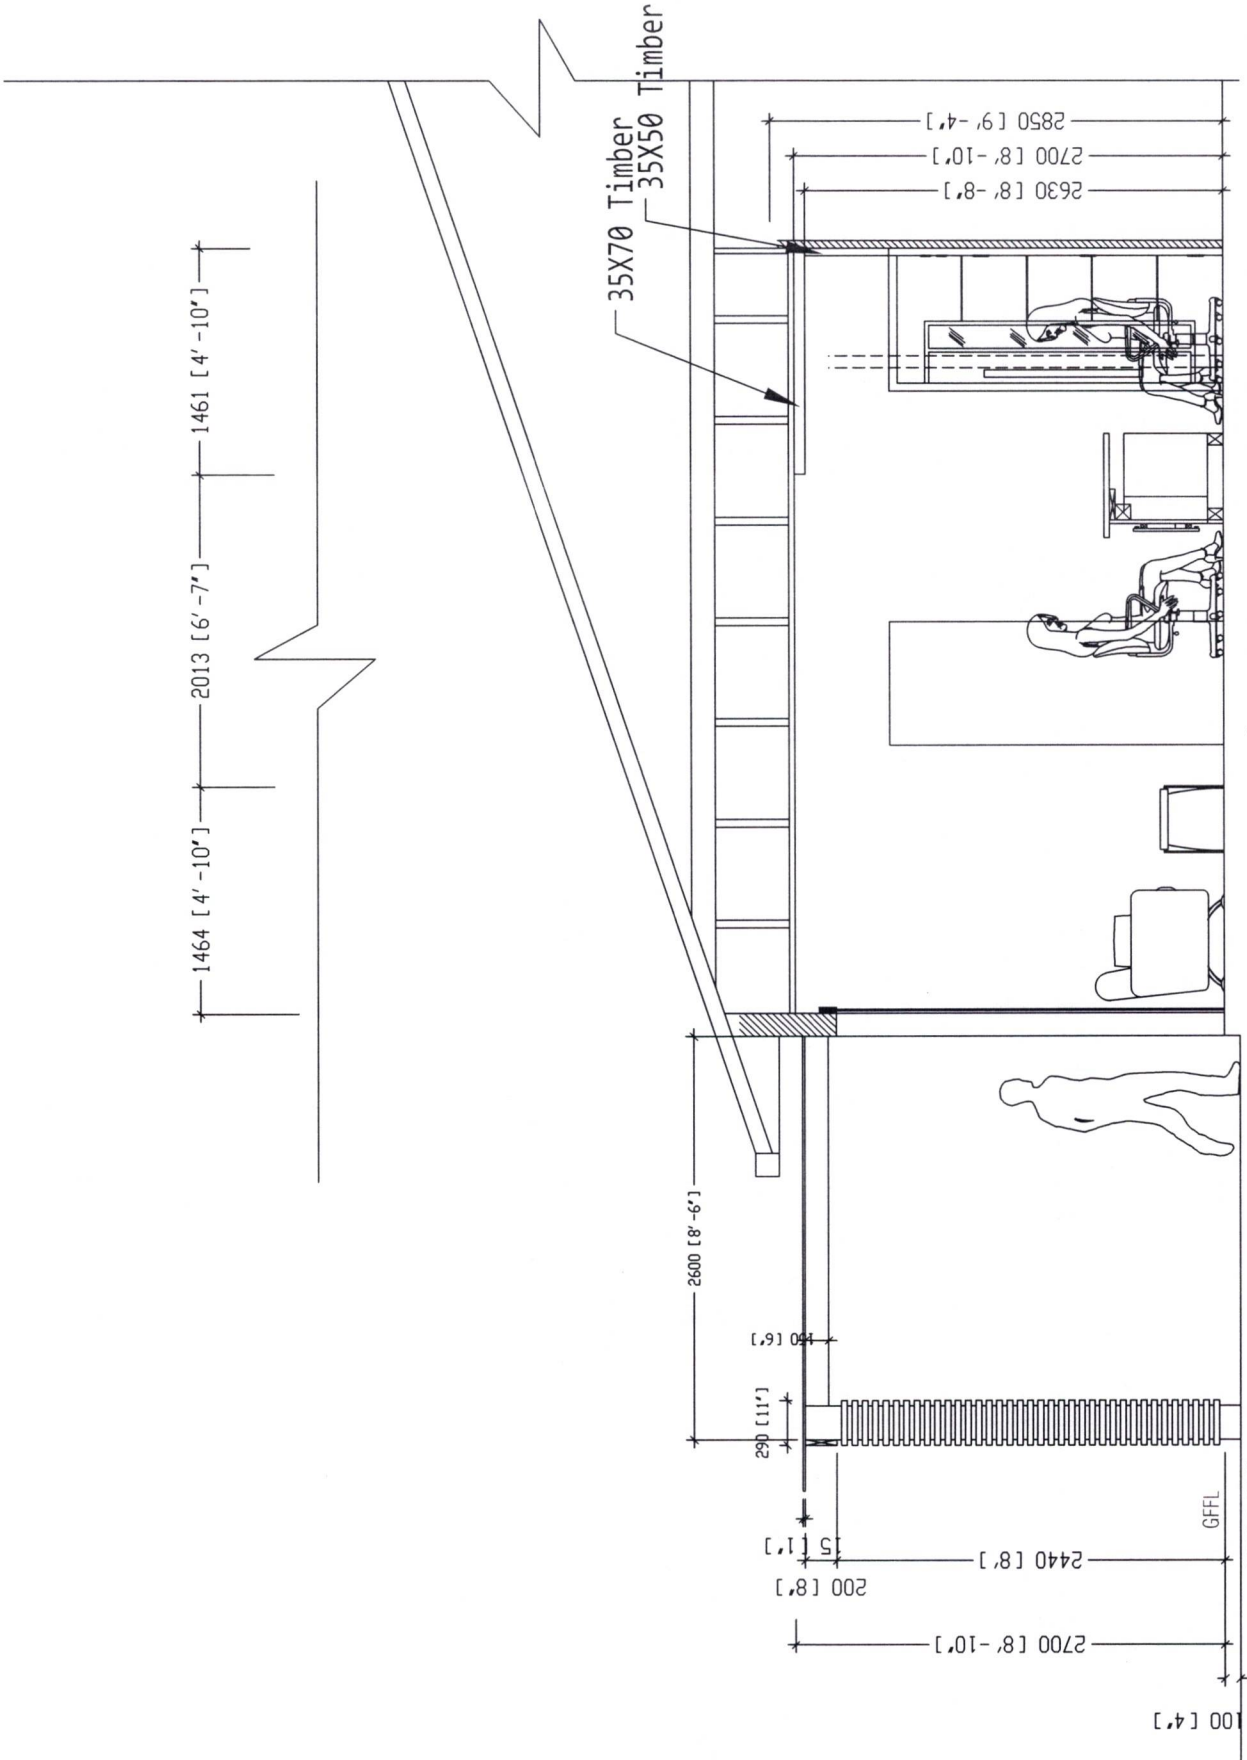


SECTIONXX
SCALE: 1:50

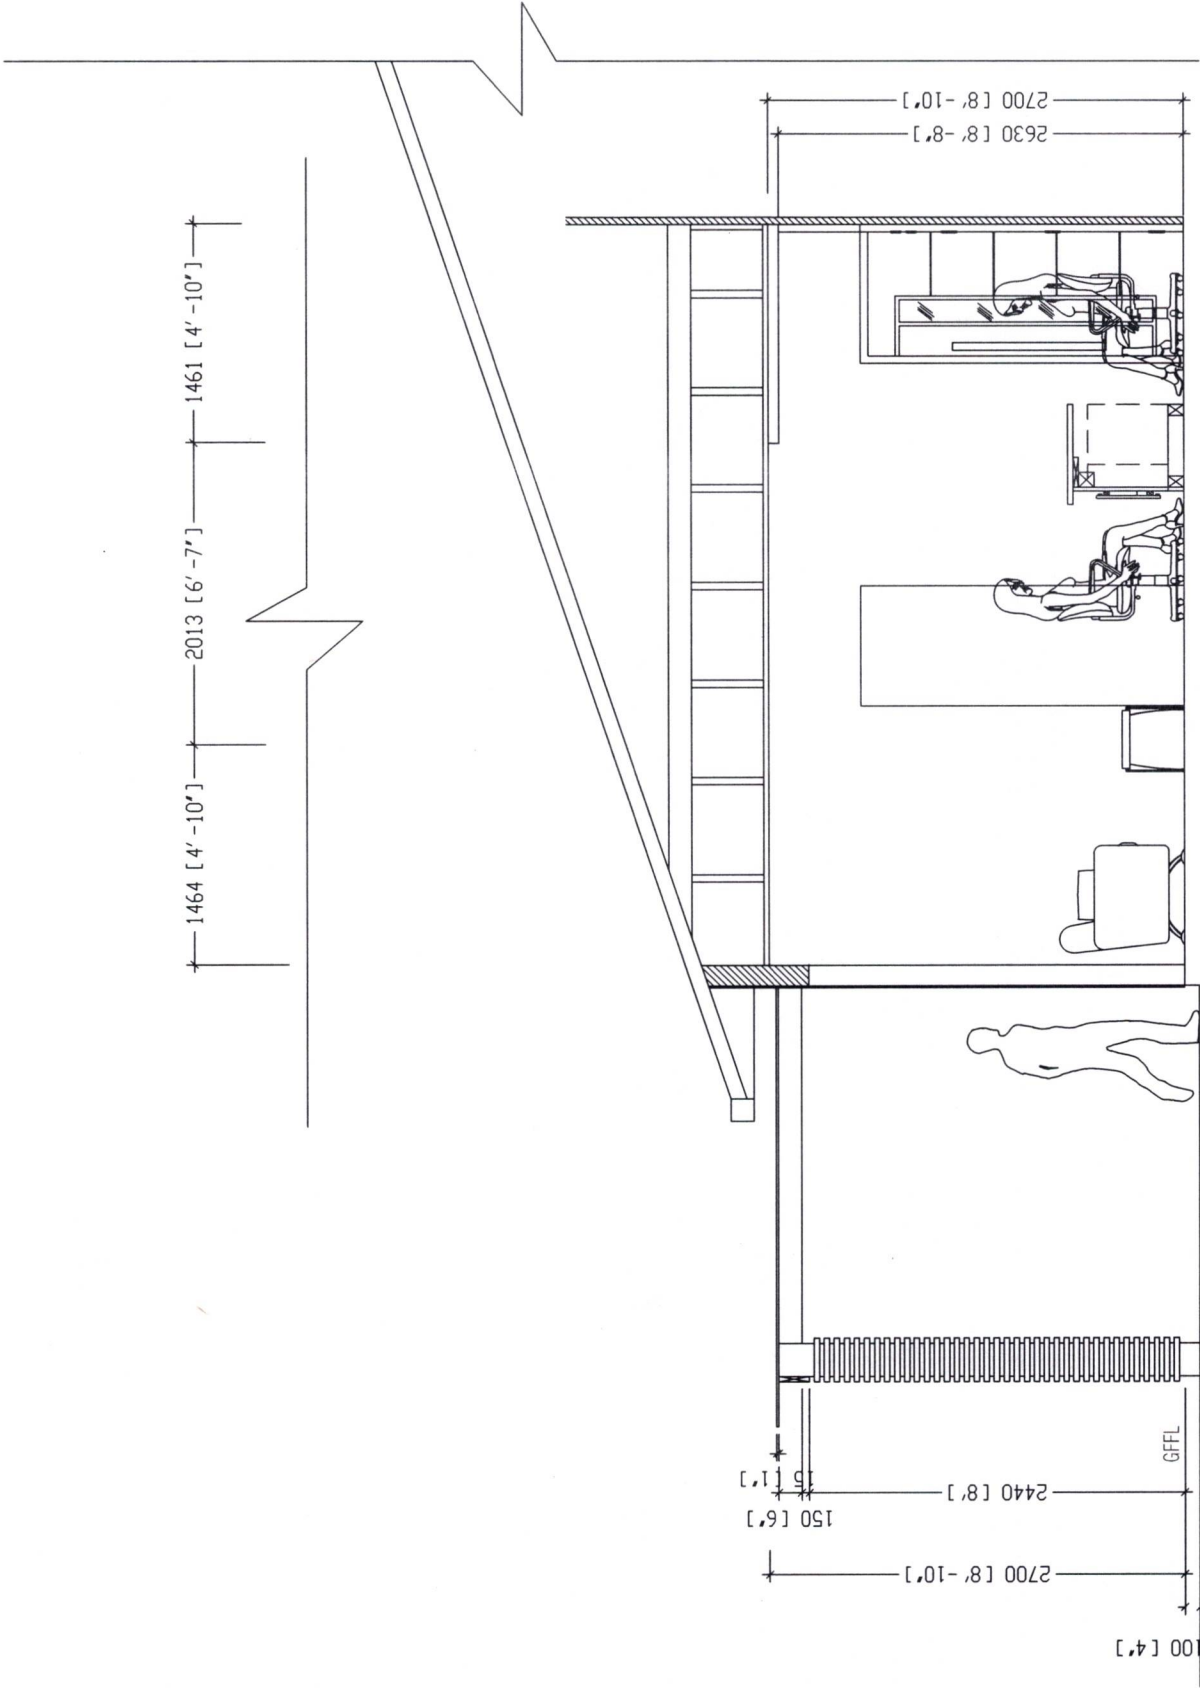

SECTION X1
SCALE: 1:50

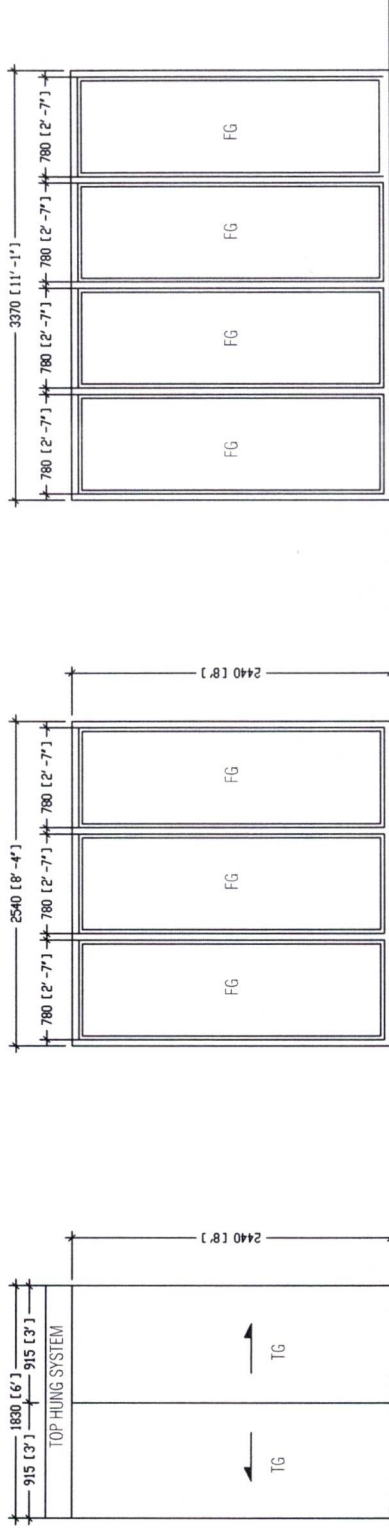

Door / QTY:	AS	01	FG2	01
Frame:	FRAMELESS			
Leal:	12MM TEMPERED GLASS			
Glazing:	-			
Ironmongery:	AUTOMATIC SYSTEM, SENSORS AND TRACKS, AND OTHERS AS REQUIRED BY THE DOOR MANUFACTURE			
Remarks:	SPECS BY MANUFACTURER AND APPROVED BY CONSULTANT ALSO PROVIDE ALLOWANCE FOR DOOR LOCK SYSTEM			
Door / QTY:	FG2	01	FG2	01
Frame:	WHITE POWEROATED ALUMINIUM			
Leal:	-			
Glazing:	8MM CLEAR GLASS			
Ironmongery:	LOCKS, DOOR HANDLE, DOOR CLOSER, KICK PLATES, HINGES WHERE REQUIRED AND AS INSTRUCTED CONSULTANT			
Remarks:	-			

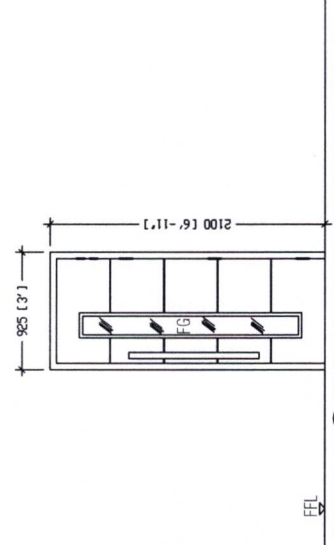

Door / QTY:	D1	01	FG2	01
Frame:	SOLID TIMBER (WITH WOOD STAIN)			
Leal:	SOLID TIMBER (WITH WOOD STAIN)			
Glazing:	8MM CLEAR GLASS			
Ironmongery:	LOCKS, DOOR HANDLE, DOOR CLOSER, KICK PLATES, HINGES WHERE REQUIRED AND AS INSTRUCTED CONSULTANT			
Remarks:	-			

NOTE

- ALL MEASUREMENTS TO BE CHECKED ON SITE BEFORE FABRICATION
- PROVIDE RC LINTEL ABOVE ALL DOOR AND WINDOW UNITS NOT FIXED TO BEAMS
- SHOP DRAWINGS ARE TO BE PROVIDED BY MANUFACTURER BEFORE FABRICATION
- ALL MATERIAL SPECS ARE TO BE PROVIDED BY THE MANUFACTURER AND APPROVED BY ARCHITECT BEFORE FABRICATION
- PROPER FIXING OPTIONS ARE TO BE PROVIDED BY THE MANUFACTURER AND APPROVED BY THE ARCHITECT

DOORS & WINDOWS
SCALE: 1:50