

Proposed Single Storey Block at Thuraakunu School
Services Drawings
Client: Ministry of Education




RIYAN PRIVATE LIMITED

t: +9603315040 f: +960330776

e: info@ryan.com.mv

w: www.ryan.com.mv

3rd Floor, H. Azum, Armeenemagui, Male'

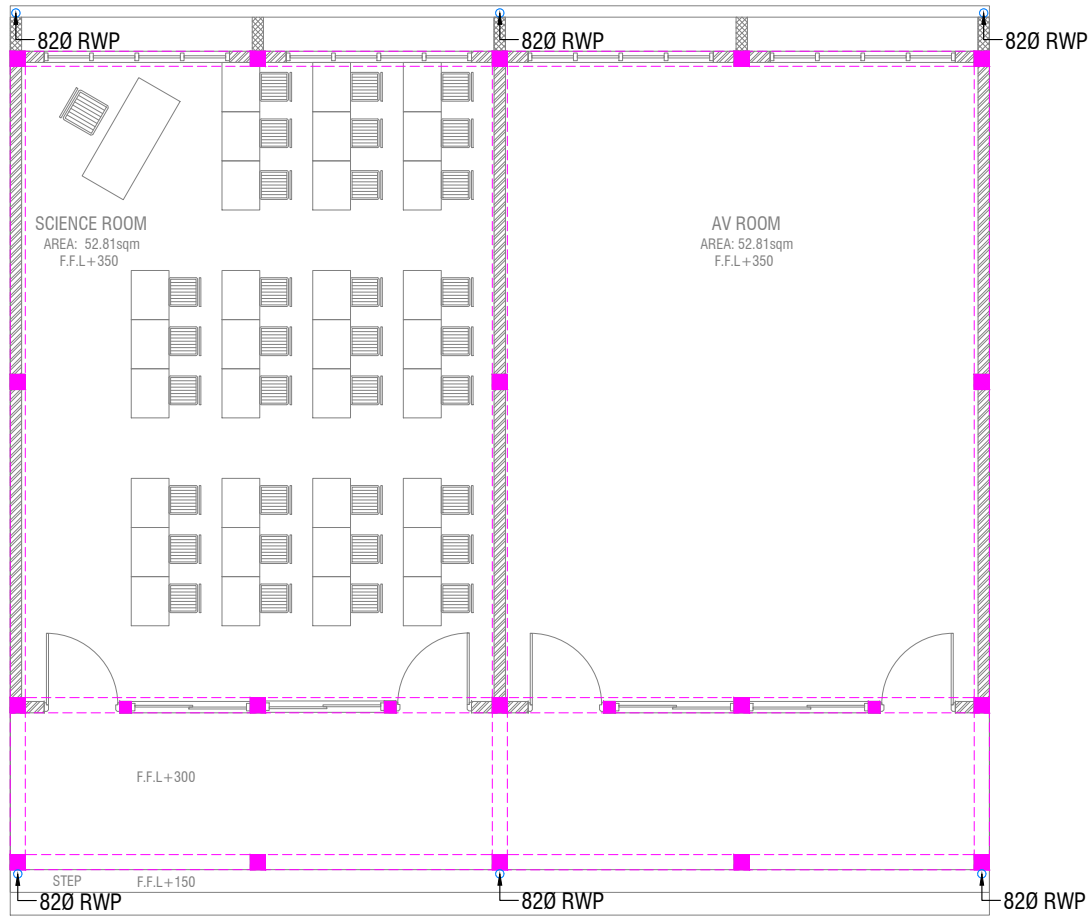

GROUND FLOOR DRAINAGE LAYOUT

SCALE 1:100



Thuraakunu School
Client: Ministry of Education

Rev no	Date
..	..
..	..
Project Number: RI/2017/012
Date: February 2018
Architect: Rizana Amir
Checked By: ..
Drawn By: ..
Services: Aishath Ahmed
Interior: ..




RIYAN PRIVATE LIMITED
t: +960315040 f: +960310776
e: ri@riyan.com.mv
w: www.riyan.com.mv
3rd Floor, H. Azum, Armeenkeemagau, Malé

Title: Ground Floor Drainage Layout

Page: DR-01/02

The contents of these drawings remain as a property of Riyon Private Limited. Any use other than those expressly stated is a violation of this copyright.

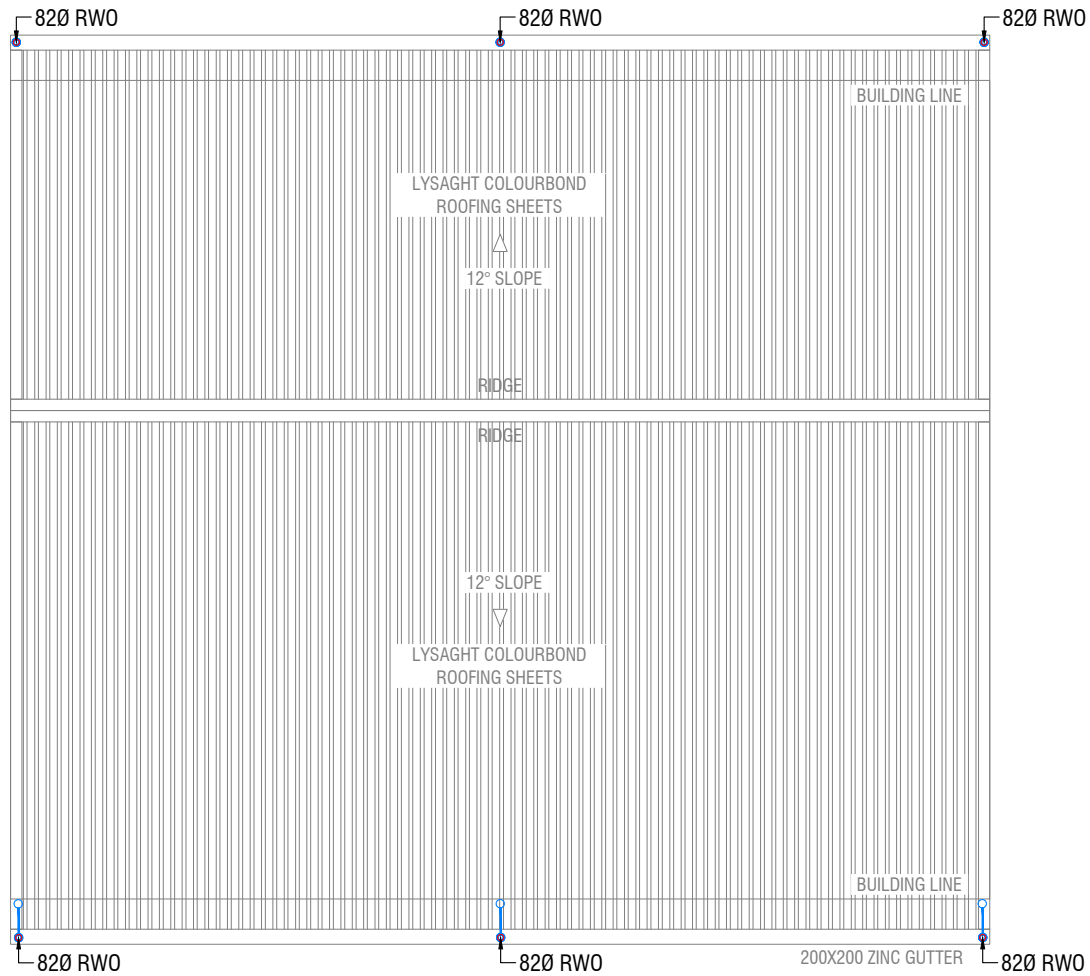

ROOF DRAINAGE LAYOUT



Thuraakunu School
 Client: Ministry of Education

Project Number: RI/2017/012
 Date: February 2018
 Architect: Rizanu Amir
 Drawn by: -
 Services: Aishath Ahmed
 Interior: -



Rev no	Date
..	..
..	..
..	..

RIYAN PRIVATE LIMITED

T: +960315040 F: +960310776
 e: info@riyan.com.mv
 w: www.riyan.com.mv
 3rd Floor, H. Azum, Ameenkeemagau, Malé

The contents of these drawings remain as a property of Riyan Private Limited. Any use other than those expressly stated is a violation of this copyright.

Title: Roof Drainage Layout
 Page: A-02/02

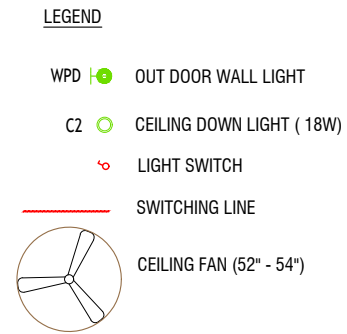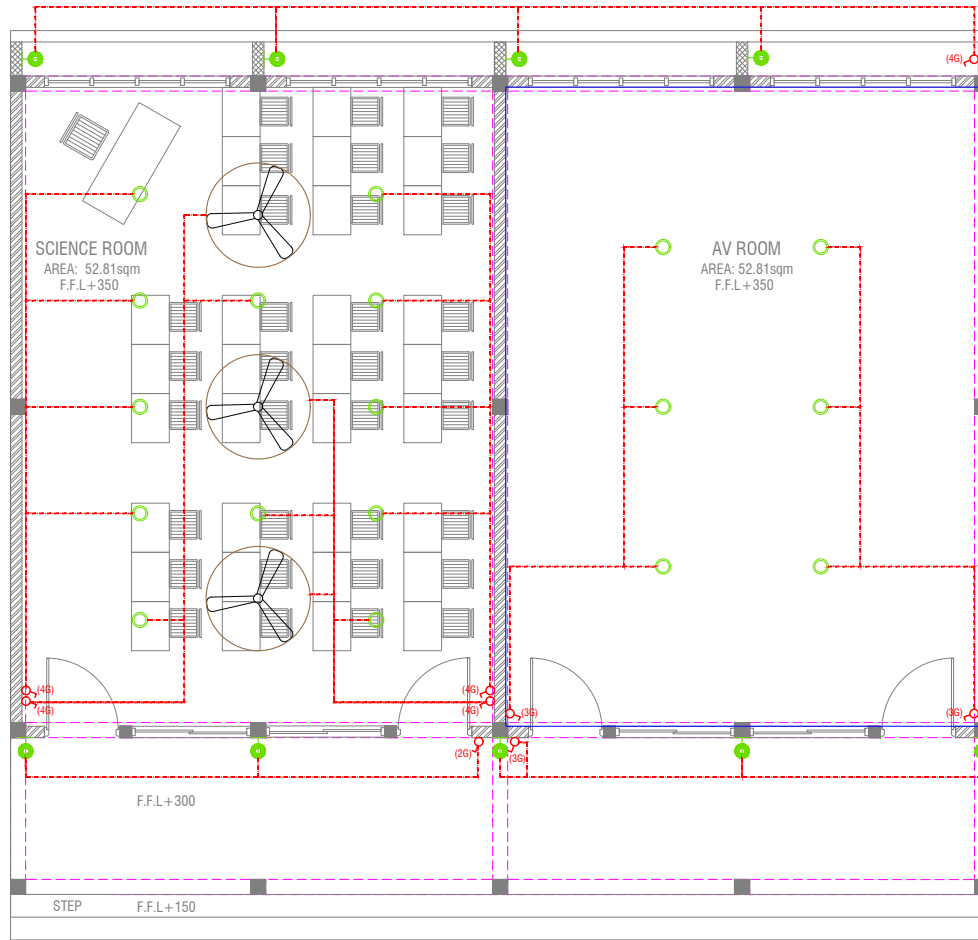

LIGHTING LAYOUT

SCALE 1:100



Thuraakunu School
Client: Ministry of Education

Project Number: RI/2017/012

Date: February 2018

Architect: Rizanu Amir

Drawn by: -

Services: Aishath Ahmed

Interior: -

Rev no

Date




RIYAN PRIVATE LIMITED

T: +960315040 F: +960310776
e: info@rivan.com.mv
w: www.rivan.com.mv
3rd Floor, H. Azum, Armeenkeemagaa, Malé

Title: Lighting Layout

Page: EL-01/01

The contents of these drawings remain as a property of Rivan Private Limited. Any use other than those expressly stated is a violation of this copyright.

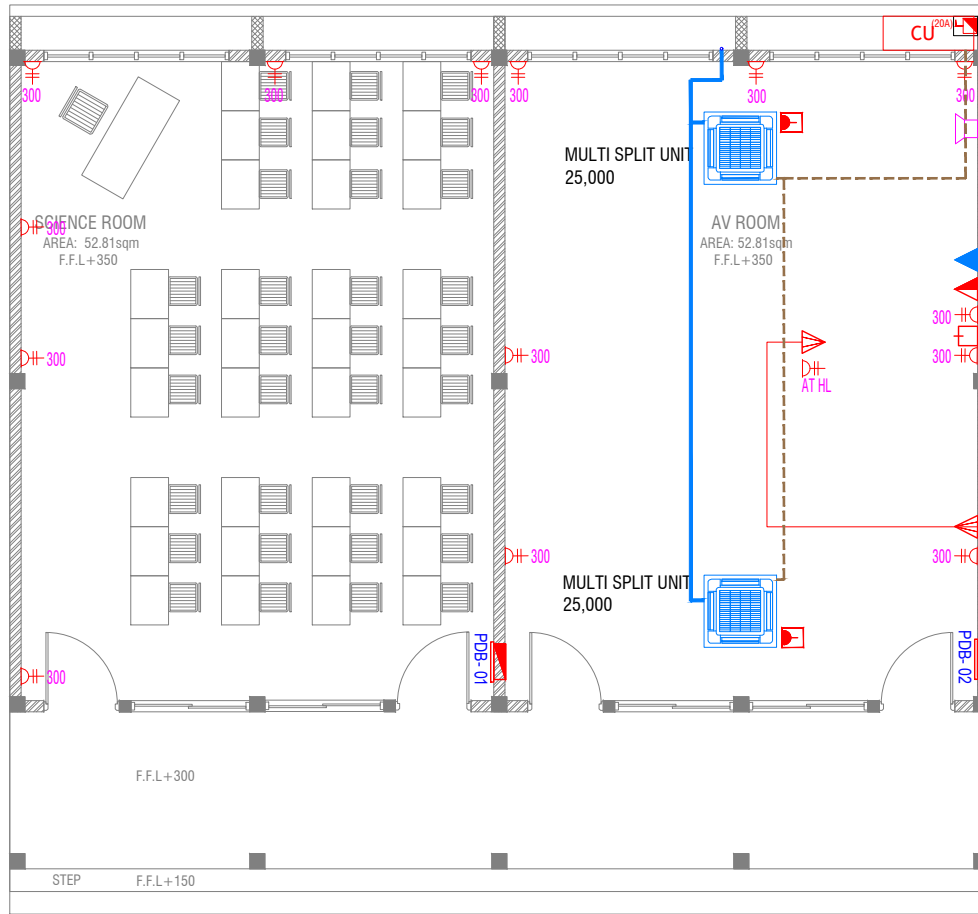

LEGEND

- PHONE EXTENSION
 - COMPUTER NETWORK OUTLET (RJ 45 CONNECTORS)
 - TELEPHONE OUTLET (RJ11, CONNECTOR)
 - 13A POWER OUTLET
 - 13A TWIN SOCKET OUTLET
 - TPN ISOLATOR
 - VGA CABLE FOR PROJECTOR
 - DISTRIBUTION BOX
 - 15A.SWITCHED/ SPUR UNIT @ H.L.
 - TWO GANG TV/SAT SOCKET OUTLET
 - SPEAKER
 - HL. HIGH LEVEL
 - WPE WEATHER PROOF POLYCARBONATE ENCLOSURE
- ALL ELECTRICAL COMPONENT TO BE CONNECTED TO THEIR RESPECTIVE DB
- REFRIGERANT PIPES
 - 25 Ø CONDENSATE DRAIN PIPE IN TRAY
 - 4-WAY CASSETTE TYPE MULTI SPLIT AC
 - VRV CONDENSING UNIT

ACV & POWER LAYOUT

SCALE 1:100

