

- OWNER'S COPY -

ARCHITECTURAL CHECKER'S CERTIFICATE

for architectural design compliance - category B1

1. I **Ali Zameer** being a registered checker, hereby certifies that I have in accordance with Male' Planning Regulation and other applicable regulations relevant to planning, design and construction of buildings set out by the Government Authorities, have carried out an evaluation and review of the drawings of the building works attached and to the best of my knowledge and belief the drawings do not show any incompliance in the design of the building to be erected or by the works carried out in accordance with those drawings.
2. In arriving at my conclusion , I confirm that I have reviewed and checked the design in accordance with the relevant regulations using the following criteria:-
 - a. rules and regulations set out by the authorities in relation to building design and construction;
 - b. codes of practice adopted in the design;
 - c. standards and specifications of materials;
 - d. architectural design concept;
 - e. architectural detailing;
 - f. appropriate checklists set out by the authorities (included with this Certificate);
 - g. others specify.....

Plot Name/No: Institute of Islamic Studies

Name of Architect: Ali Zameer


City/Atoll/Island: **K.Male'**


Date: **09-Jan-20**

Type of Building (use) : **Commercial**

Checker's Reg. Number: **BPR2017029B1**

Plot Owner's Name:

Checker's Signature: 

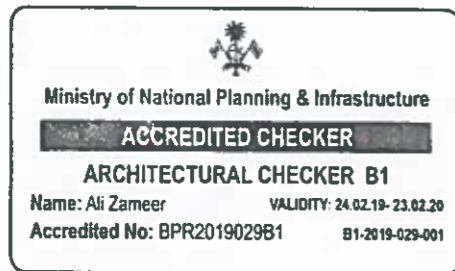

Official Stamp of the Registered Architectural Checker

FOR OFFICIAL USE ONLY

Building Permit No.:

D-2001/465 (5/2/2020)

Local Authority's Stamp




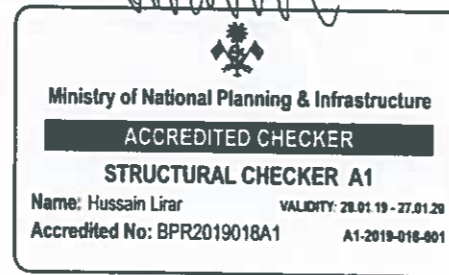
THE CERTIFICATE

For Structural Design Compliance - Category A1

1. I ...HUSSAIN LIRAR...being a registered accredited professional, hereby certifies that I have in accordance with this National Building Professionals Accreditation Regulation set out by the Registrar, have carried out an evaluation, analysis and review of the plans of the building works attached and to the best of my knowledge and belief the plans do not show any inadequacy in the key structural elements of the building to be erected or by the works carried out in accordance with those plans.
2. In arriving at my conclusion , I confirm that I have reviewed and evaluated the design in accordance with the building regulations using the following criteria:-
 - a. codes of practice adopted in the design;
 - b. including wind load, construction load or dynamic load, if applicable) checked;
 - c. standards and specifications of structural elements;
 - d. structural design concept and identification of the key structural elements;
 - e. structural analysis and design of all key structural elements including foundation systems;
 - f. stability of structural frame;
 - g. structural detailing;
 - h. others specify.....



Plot Name/No: Islamic University of Maldives
City/Atoll/Island: K/ Male'
Type of Building: University
Plot Owner's Name: Institute of Islamic Studies

Name of Engineer: Ali Akram
Date: 30th Dec 2019
Checker's Reg. Number:
Checker's Signature: 



Official Stamp of the
Accredited Professional Engineer

FOR OFFICIAL USE ONLY


Building Permit No.: <i>D-2001/465 (5/2/2020)</i>	Local Authority's Stamp APPROVED PERMIT No: <i>D-2001/465</i> DATE: <i>5/2/2020</i> SIGNATURE: 
 SECRETARIAT OF THE MALE' CITY COUNCIL MALE', REPUBLIC OF MALDIVES	

MODIFICATION OF 7TH (TERRACE) FLOOR

INSTITUTE OF ISLAMIC STUDIES
ARCHITECTURAL & STRUCTURAL DRAWINGS

CLIENT:
INSTITUTE OF ISLAMIC STUDIES

DATE:
DEC, 2019

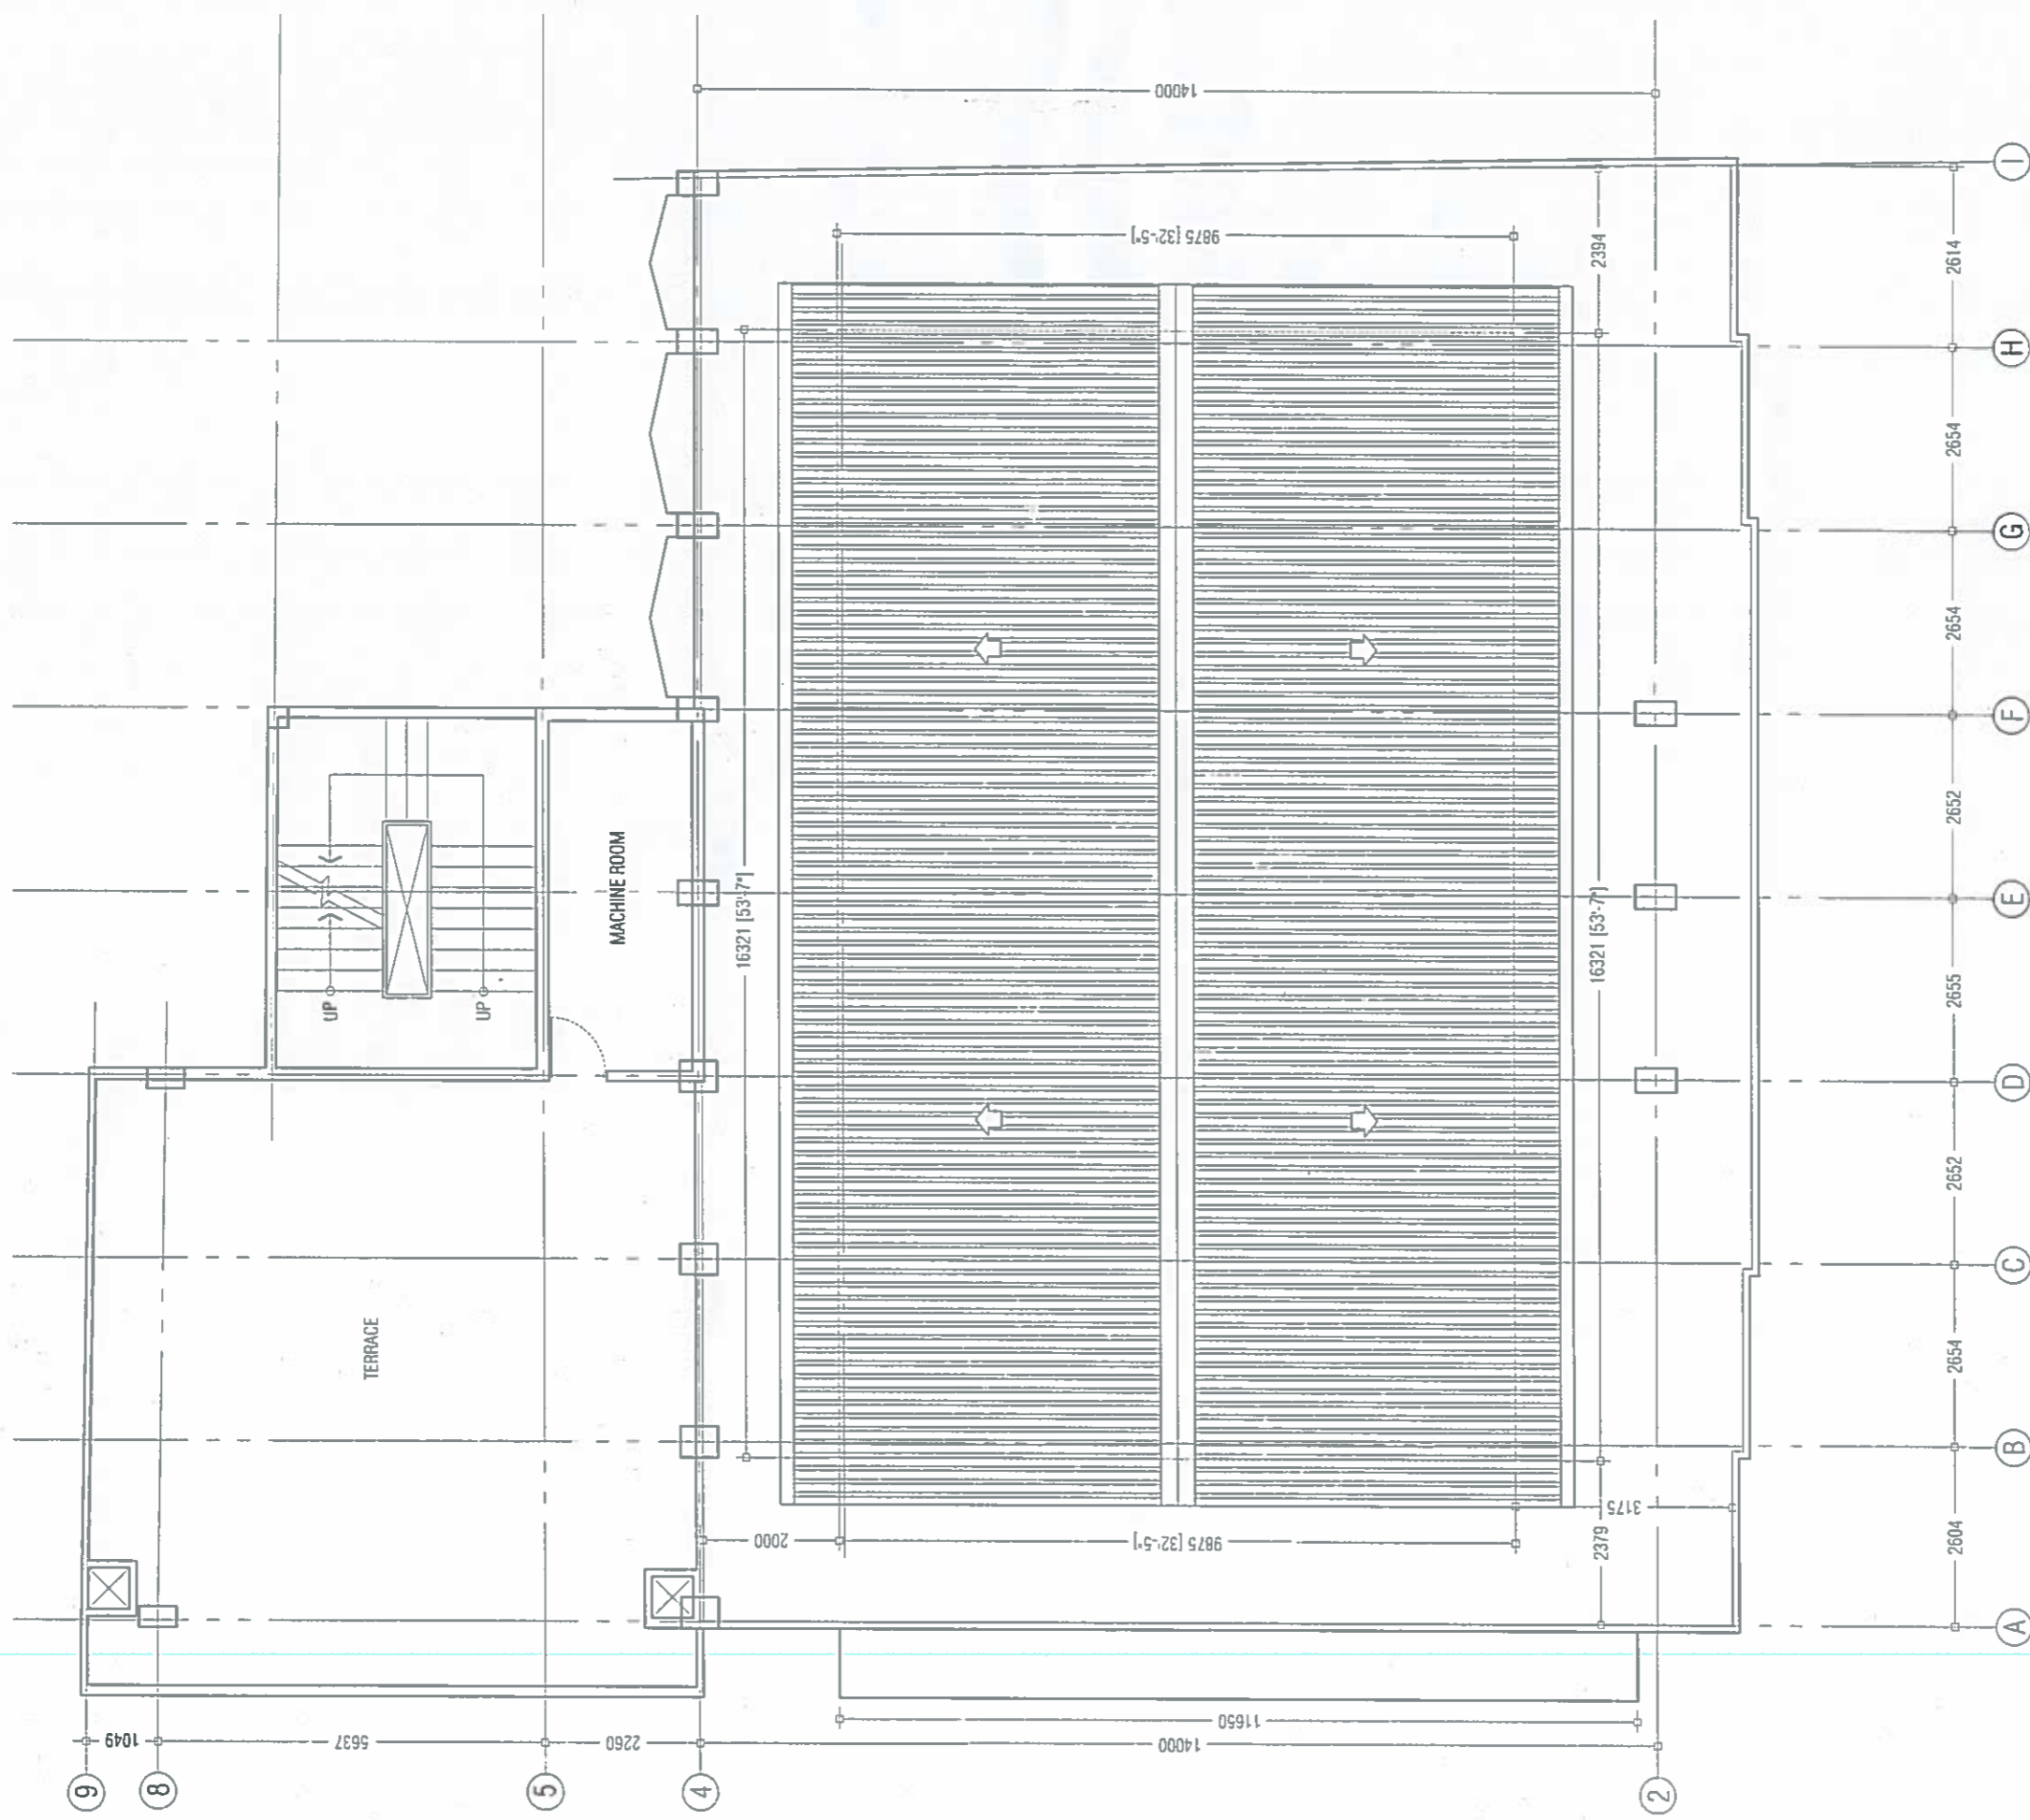


ACCREDITED CHECKER
 ARCHITECTURAL CHECKER B1
 Name: Ali Zameer
 Accredited No: BPR2019029B1
 VALIDITY: 24.02.19 - 23.02.29
 B1-2019-029-001

EXISTING 7TH (TERRACE) FLOOR PLAN
 Scale 1:100

APPROVED
 PERMIT No: D-2001/465
 DATE: 5/2/2020
 SIGNATURE: 
 SECRETARY OF THE MALE ARCHITECTURAL BOARD
 MALE, REPUBLIC OF MALDIVES



ACCREDITED CHECKER
 STRUCTURAL CHECKER A1
 Name: Hussain Lrar
 Accredited No: BPR2019018A1
 VALIDITY: 28.01.19 - 27.01.29
 A1-2019-018-001

DWG NO: A01

PROJECT TITLE : INSTITUTE OF ISLAMIC STUDIES - 7TH FLOOR RENOVATION
 CLIENT : INSTITUTE OF ISLAMIC STUDIES
 SHEET CONTENTS : AS GIVEN

ARCHITECTURE: MOHAMED YOUSUF
 ENGINEER : ALI ANRAM
 DRAWN BY : MOHAMED SAMIR
 SCALE: 1:100
 DATE ISSUED : DEC 2019
 FILE : INSTITUTE OF ISLAMIC STUDIES.rvt
 REVISION NO. :


Rimaas
 pvt. ltd
 NATIONAL CADASTRAL SURVEY
 ARCHITECT MALDIVE
 REPUBLIC OF MALDIVES
 TEL: 960 777 7761
 P: 001 239991001

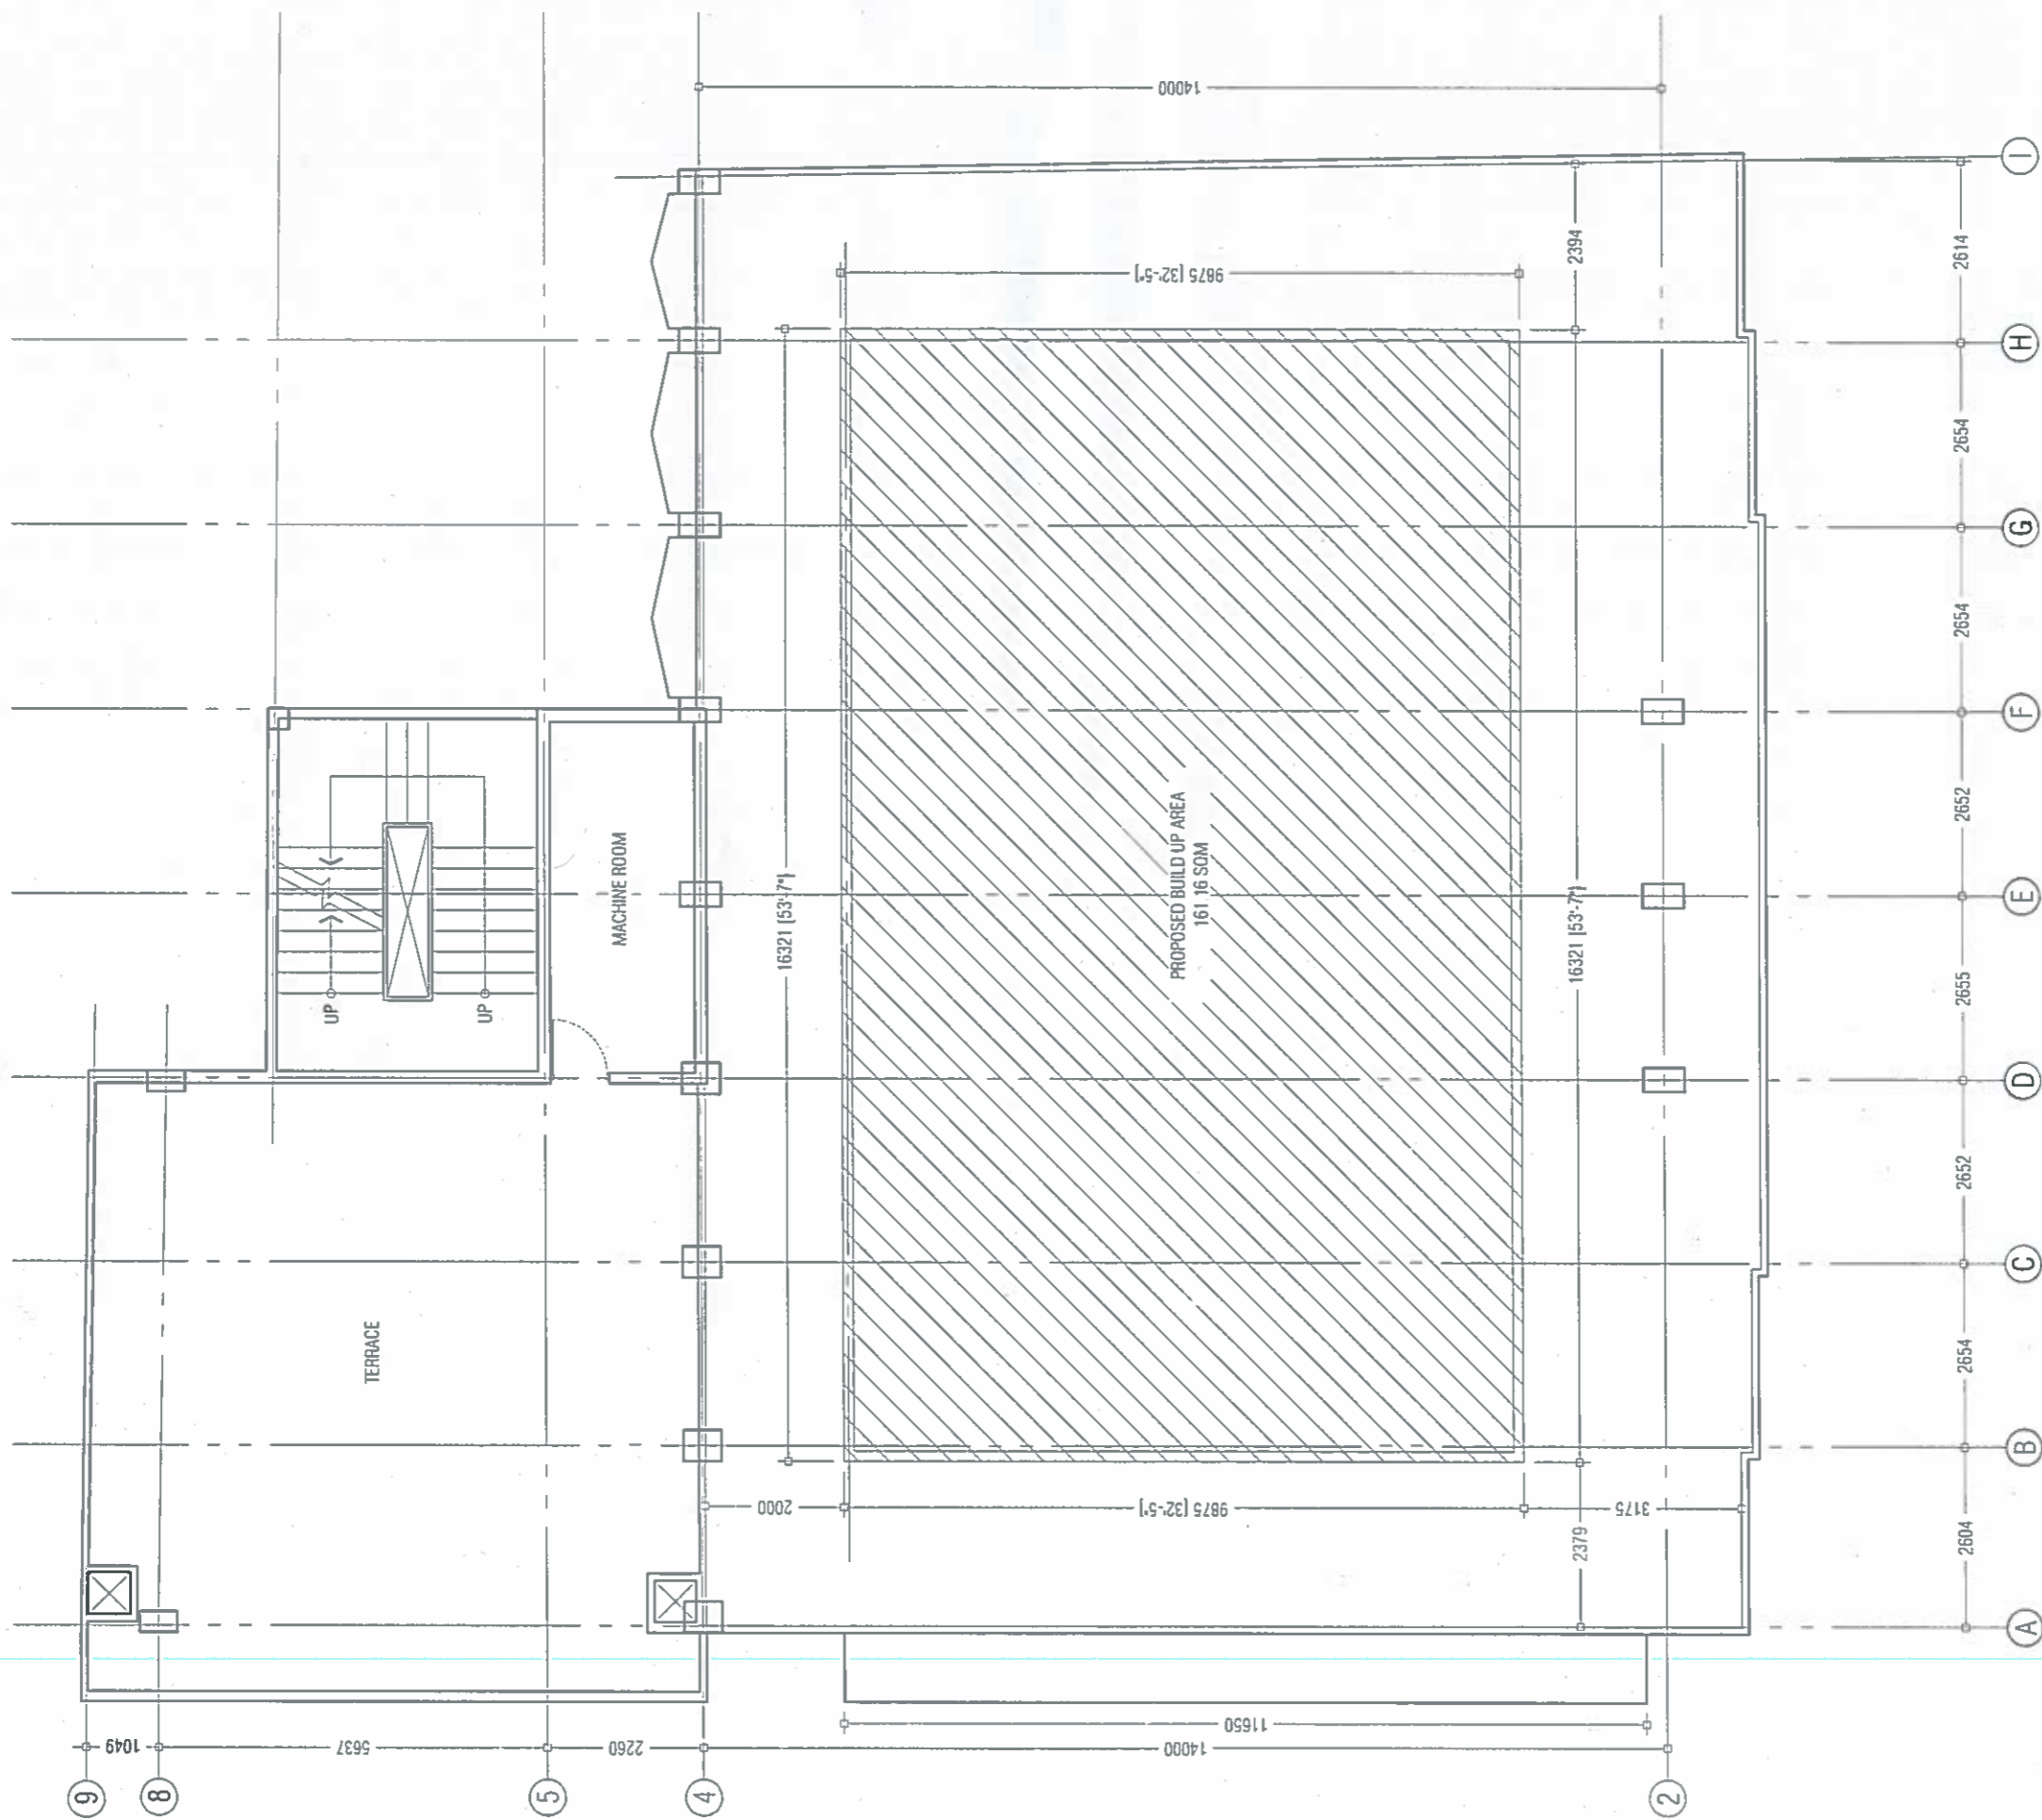


PROPOSED BUILD UP AREA = 161. SOM



PROPOSED SITE PLAN
Scale: 1:100


Ministry of National Planning & Infrastructure
ACCREDITED CHECKER
STRUCTURAL CHECKER A1
 Name: Hussain Lilar VALIDITY: 28.01.19 - 27.01.20
 Accredited No: BPR201801BA1 A1-2019-018-001

 

Ministry of National Planning & Infrastructure
ACCREDITED CHECKER
ARCHITECTURAL CHECKER B1
 Name: Ali Zameer VALIDITY: 24.02.19 - 23.02.20
 Accredited No: BPR2019029B1 B1-2019-029-001


Rimaas pvt. Ltd.
 100% LOCAL COMPANY
 100% LOCAL INVESTMENT
 100% LOCAL EMPLOYMENT

DWG NO: A02

PROJECT TITLE :	INSTITUTE OF ISLAMIC STUDIES	ARCHITECTURE :	MOHAMED YOUSUF	SCALE :	1:100
CLIENT :	7TH FLOOR, MOHAMED YOUSUF	ENGINEER :	ALI ARSAM	DATE ISSUED :	DEC-2019
SHEET CONTENTS :	AS GIVEN	DRAWN BY :	MOHAMED SAMIR	FILE :	INSTITUTE OF ISLAMIC STUDIES DWG
				REVISION NO. :	

IN INDEPENDENT LAND FOR SALE
 PAPER NO: 1400
 NAME OF THE SITE
 100% LOCAL INVESTMENT
 100% LOCAL EMPLOYMENT
 100% LOCAL COMPANY
Rimaas pvt. Ltd.

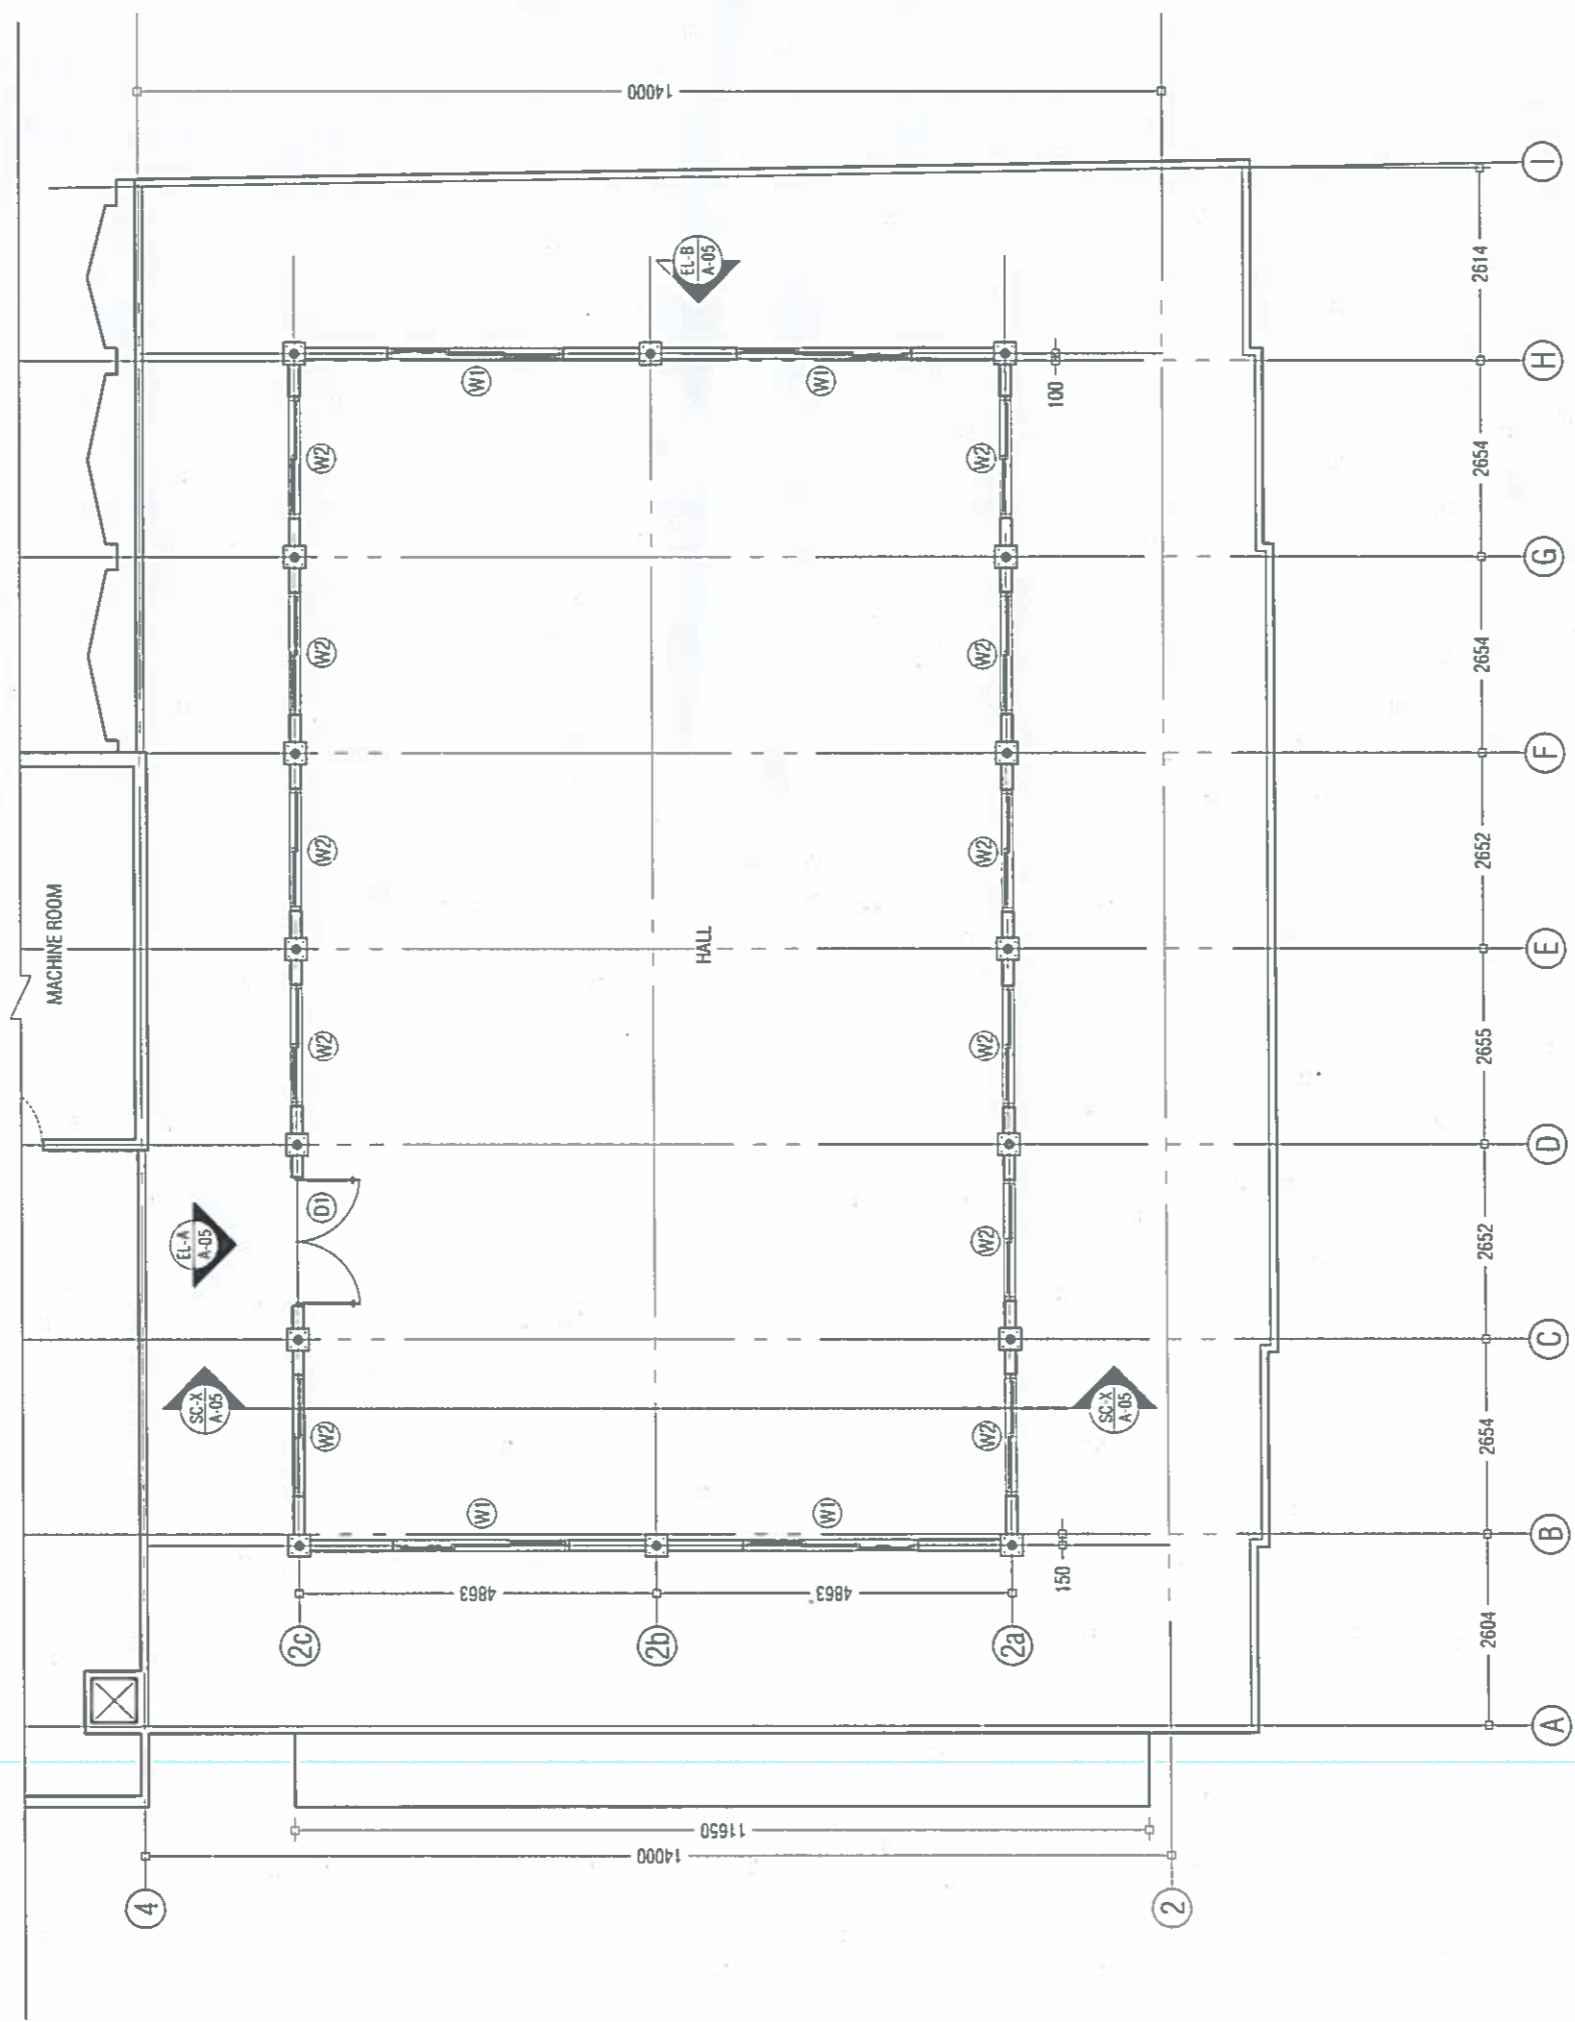

PROPOSED 7TH (TERRACE) FLOOR PLAN
Scale: 1:100


Ministry of National Planning & Infrastructure
ACCREDITED CHECKER
STRUCTURAL CHECKER A1
 Name: Hussain Lrar VALIDITY: 28.01.19 - 27.01.20
 Accredited No: BPR2019018A1 A1-2019-018-001


Ministry of National Planning & Infrastructure
ACCREDITED CHECKER
ARCHITECTURAL CHECKER B1
 Name: Ali Zameer VALIDITY: 24.02.19 - 23.02.20
 Accredited No: BPR2019029B1 B1-2019-029-001




DWG NO:
A03

PROJECT TITLE : 7TH FLOOR MODIFICATION
 CLIENT : INSTITUTE OF ISLAMIC STUDIES
 SHEET CONTENTS : AS GIVEN

ARCHITECTURE: MOHAMED YOUSUF
 ENGINEER : ALI ANDRAM
 DRAWN BY : MOHAMED SAHIR

Rimaas
 pvt. Ltd
 IS A REGISTERED CORPORATION
 HAILUOHE (MOU)
 BANK
 REP. OF SAUDI ARABIA
 No. 1030/17/1400
 P.O. Box: 1030/17/1400

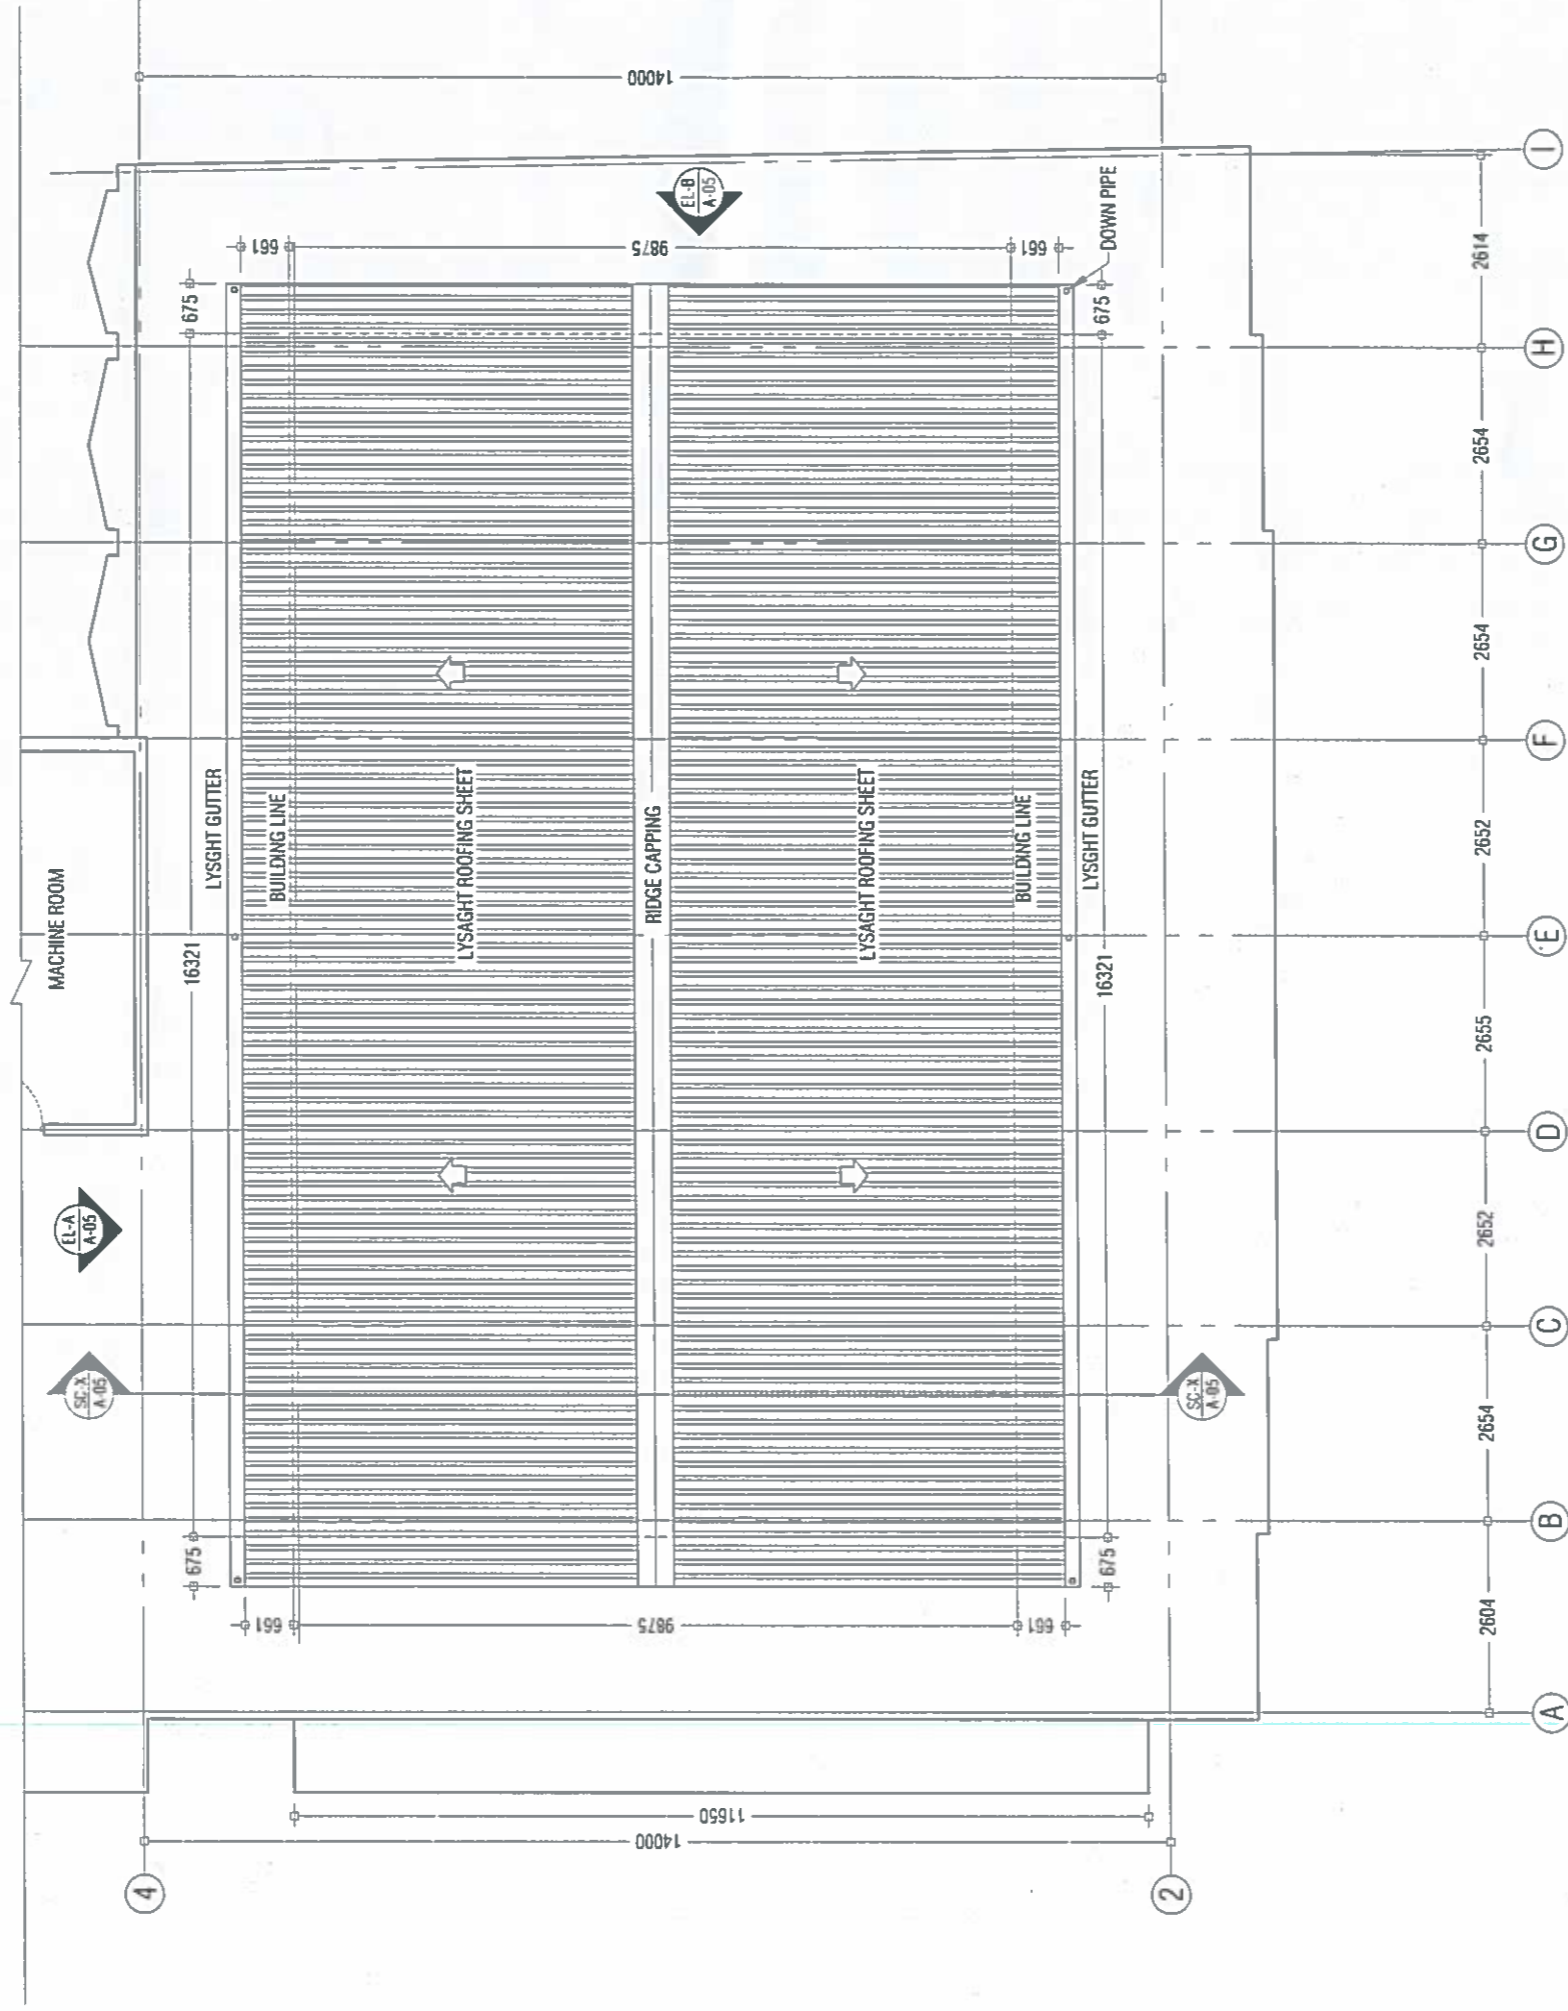

ROOF PLAN
Scale 1:100


Ministry of National Planning & Infrastructure
ACCREDITED CHECKER
STRUCTURAL CHECKER A1
 Name: Hussain Litar VALIDITY: 28.01.19 - 27.01.20
 Accredited No: BPR2019018A1 A1-2019-018-001


Ministry of National Planning & Infrastructure
ACCREDITED CHECKER
ARCHITECTURAL CHECKER B1
 Name: Ali Zameer VALIDITY: 24.02.19 - 23.02.20
 Accredited No: BPR201902981 B1-2019-029-001


Rimaas
 Rimaas Engineering & Architecture
 P.O. Box 111, Jeddah 21511, Saudi Arabia
 Tel: +966 11 221 7361
 E-mail: rimaas@rimaas.com

DWG NO:

A04

PROJECT TITLE : 27th FLOOR ADDITION

CLIENT : INSTITUTE OF ISLAMIC STUDIES

SHEET CONTENTS : AS GIVEN

ARCHITECTURE: MOHAMED YOUSUF

ENGINEER : ALI AKRAM

DRAWN BY : MOHAMED SAMIR

SCALE: 1:100

DATE ISSUED : DEC. 2019

REVISION NO.:

INSTITUTE OF ISLAMIC STUDIES


UNIT

REG. NO. 111/111/111


TEL: (966) 111 7361

E-MAIL: rimaas@rimaas.com


Rimaas
pvt. Ltd

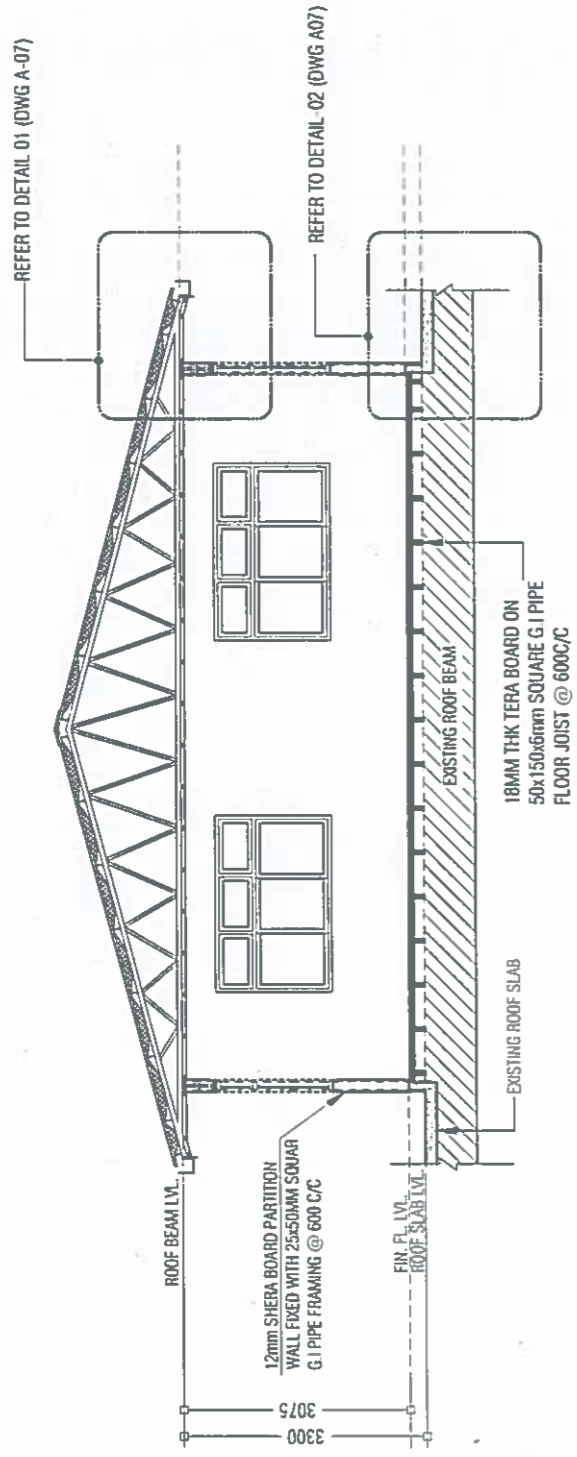

SECTION X-X
Scale 1:100

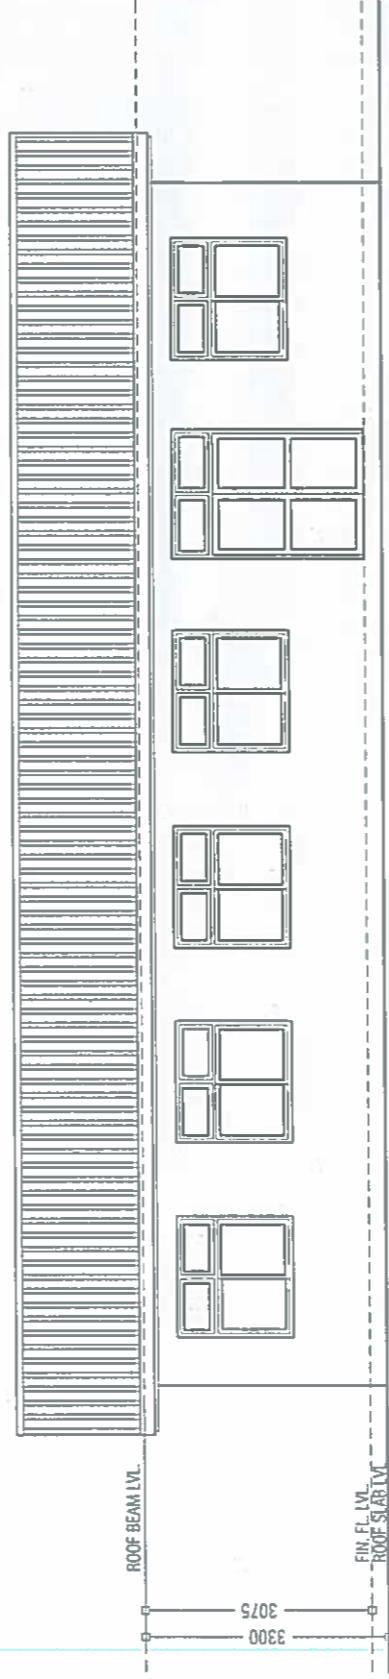

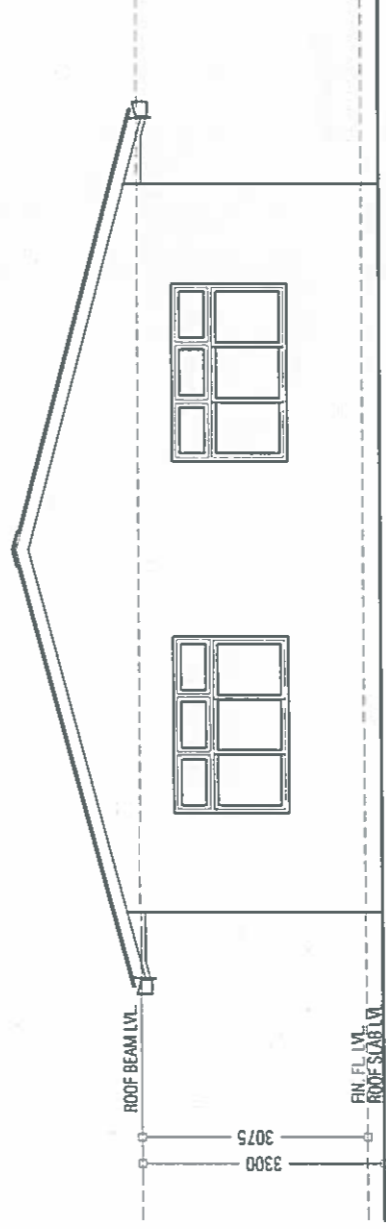

ELEVATION-A
Scale 1:100



ELEVATION-B
Scale 1:100


 Ministry of National Planning & Infrastructure
ACCREDITED CHECKER
STRUCTURAL CHECKER A1
 Name: Hussain Litar VALIDITY: 28.01.19 - 27.01.20
 Accredited No: BPR2019018A1 A1-2019-018-001


 Ministry of National Planning & Infrastructure
ACCREDITED CHECKER
ARCHITECTURAL CHECKER B1
 Name: Ali Zameer VALIDITY: 24.02.19 - 23.02.20
 Accredited No: BPR2019029B1 B1-2019-029-001


 ريماس
 مؤسسة
 للتخطيط والتنمية
 505


DWG NO:
A05

PROJECT TITLE : INSTITUTE OF ISLAMIC STUDIES - ZIELEFLOOR RECONSTRUCTION
 CLIENT : INSTITUTE OF ISLAMIC STUDIES
 SHEET CONTENTS : AS GIVEN

ARCHITECTURE : MOHAMED YOUSUF
 ENGINEER : ALI AKRAM
 DRAWN BY : MOHAMED SAMIR

SCALE: 1:100
 DATE ISSUED : DEC-2019
 FILE : MINISTRY OF ISLAMIC STUDIES.DWG
 REVISION NO. :

Rimaas
 priv. Ltd
 M. INDRANIGA GANDESHALE
 MALE
 P.O. BOX 1145
 TEL: 00967 111 1261
 e-mail: info@rimaas.com

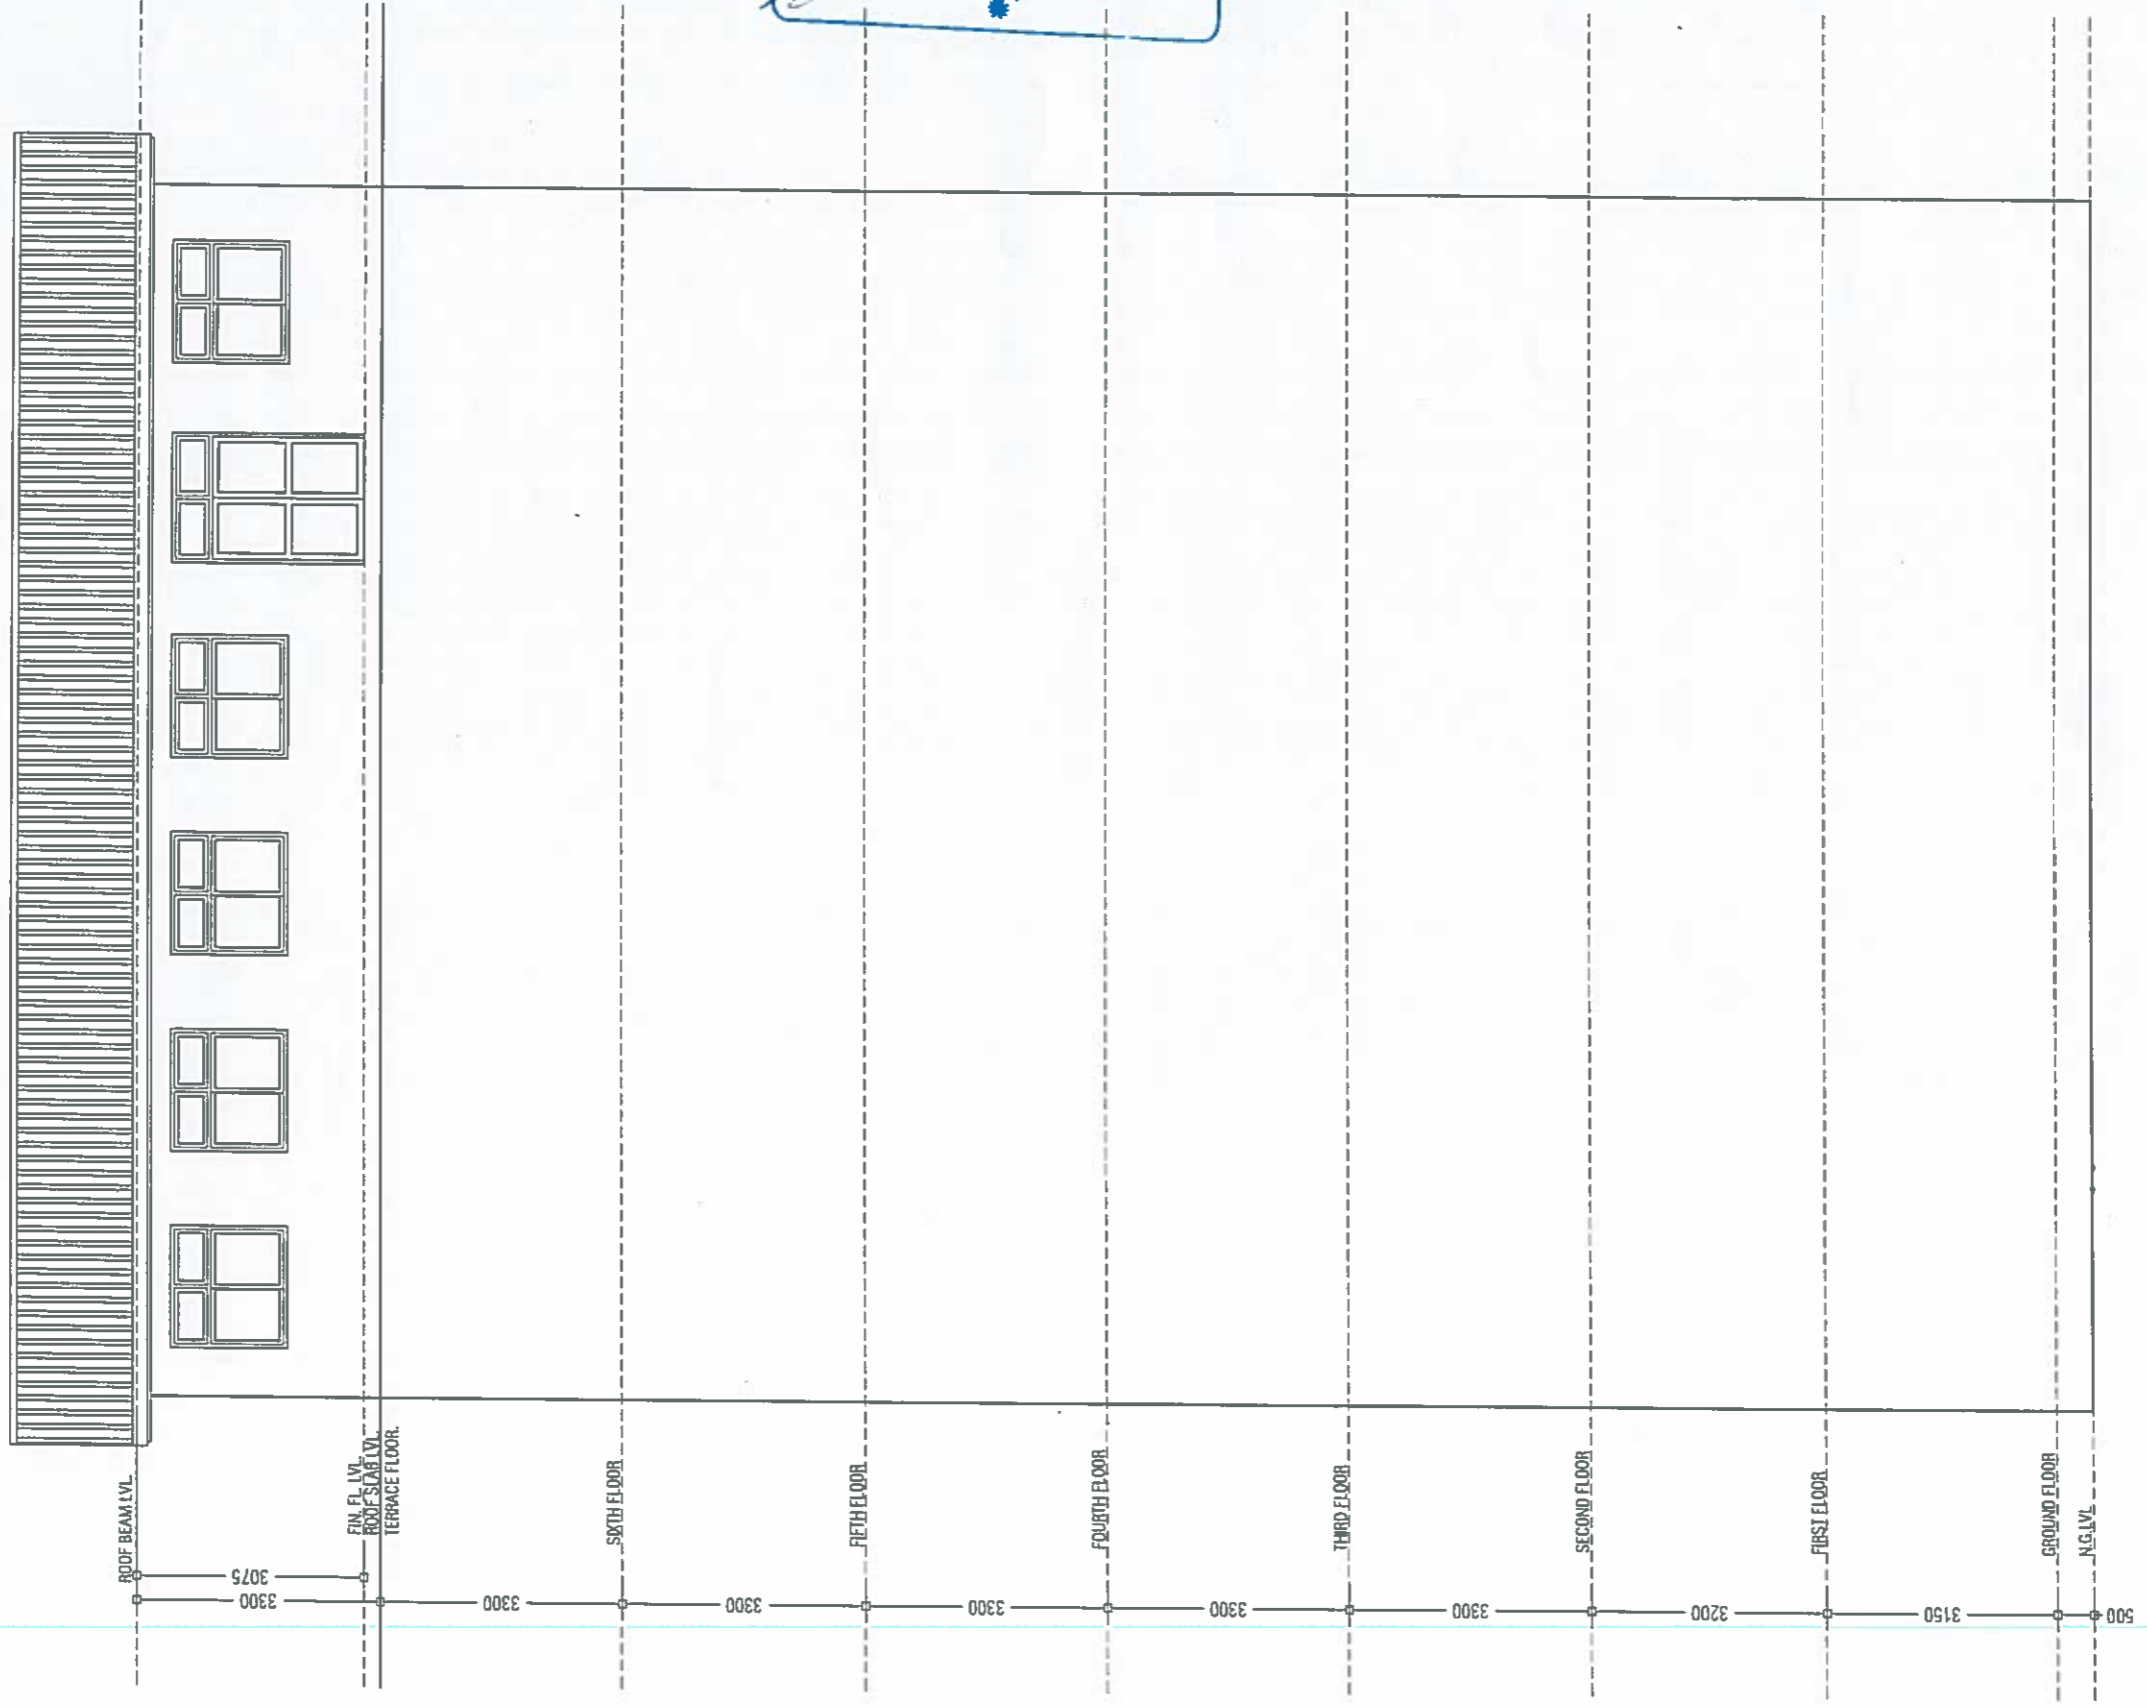

Ministry of National Planning & Infrastructure
ACCREDITED CHECKER
 ARCHITECTURAL CHECKER B1
 Name: Ali Zameer
 VALIDITY: 26.02.19 - 23.02.20
 Accredited No: BPR2019029B1
 B1-2019-029-001

Ministry of National Planning & Infrastructure
ACCREDITED CHECKER
 STRUCTURAL CHECKER A1
 Name: Hussain Litar
 VALIDITY: 28.01.19 - 27.01.20
 Accredited No: BPR2019018A1
 A1-2019-018-001

ELEVATION-A
 Scale 1:100




DWG NO:
A05b

PROJECT TITLE : INSTITUTE OF ISLAMIC STUDIES - 7TH FLOOR MODIFICATION
 CLIENT : INSTITUTE OF ISLAMIC STUDIES
 SHEET CONTENTS : AS GIVEN

ARCHITECTURE: MOHAMED YOUSUF
 ENGINEER : ALI AKRAM
 DRAWN BY : MOHAMED SAMIR
 SCALE: 1:100
 DATE ISSUED : DEC-2019
 FILE : INSTITUTE OF ISLAMIC STUDIES.DWG
 REVISION NO. :

Rimaas
 priv. Ltd
 IS A PROFESSIONAL ENGINEERING FIRM
 REGISTERED UNDER
 THE REGISTRATION
 ACT OF MALDIVES
 TEL: 0091 777 7001
 E-mail: rimaas@rmaas.com

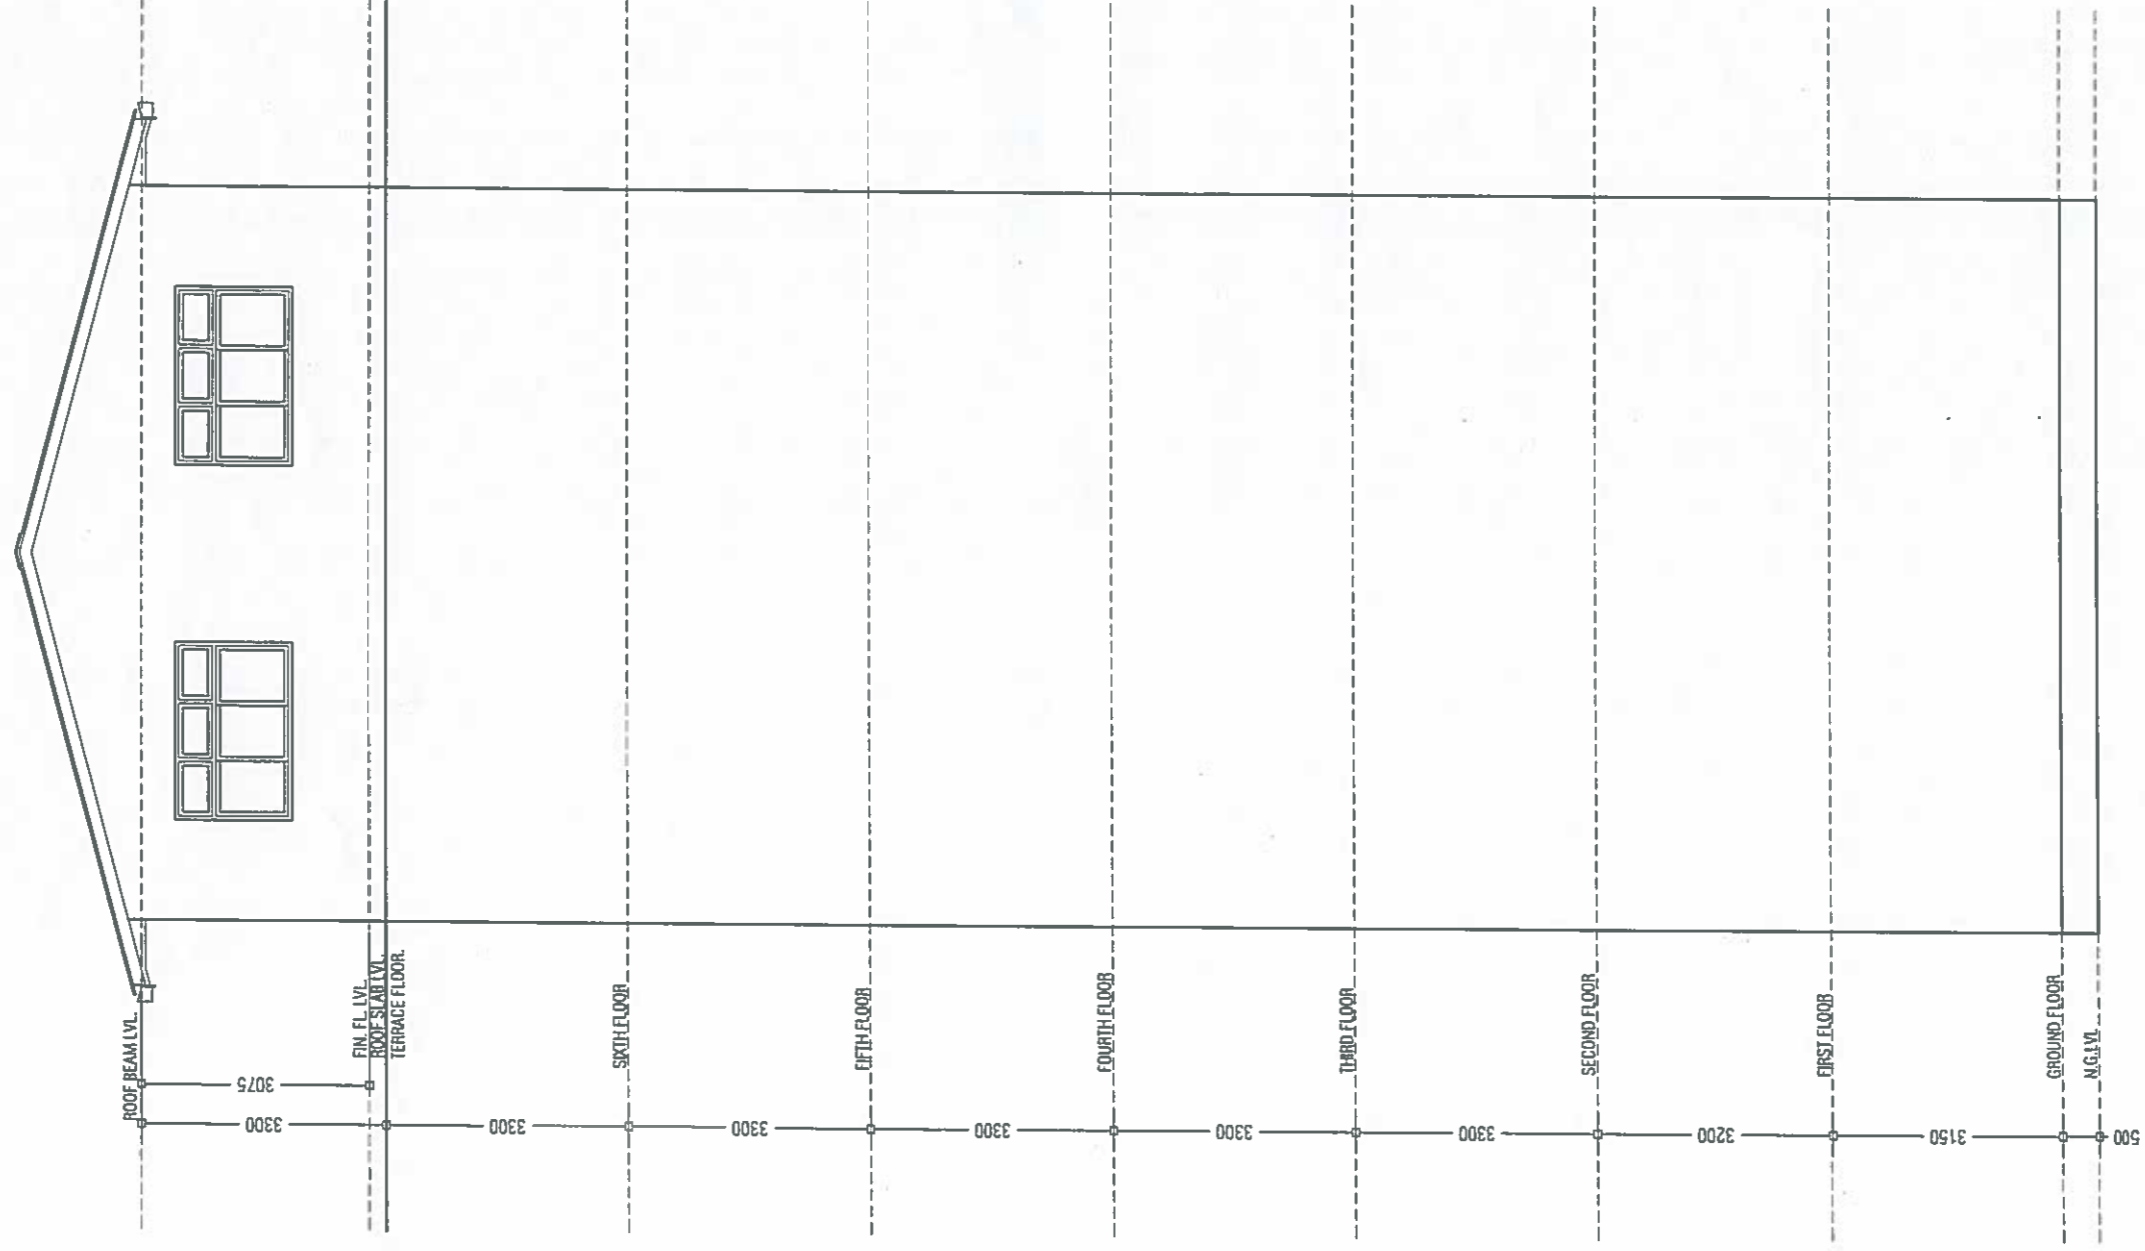

ELEVATION-B

Scale : 1:100


Ministry of National Planning & Infrastructure
ACCREDITED CHECKER
STRUCTURAL CHECKER A1
 Name: Hussain Lizar VALIDITY 28.01.19 - 27.01.20
 Accredited No: BPR2019018A1 AI-2018-018-001


معهد الدراسات الإسلامية
 المعهد الإسلامي للدراسات والبحوث
 2019



Ministry of National Planning & Infrastructure
ACCREDITED CHECKER B1
ARCHITECTURAL CHECKER B1
 Name: Ali Zameer VALIDITY 24.02.19 - 23.02.20
 Accredited No: BPR2019029B1 AI-2019-029-001

DWG NO: A05C

PROJECT TITLE : INSTITUTE OF ISLAMIC STUDIES - 7TH FLOOR, MODERAZIYAH
 CLIENT : INSTITUTE OF ISLAMIC STUDIES
 SHEET CONTENTS : AS GIVEN

ARCHITECTURE: MOHAMMED YOUSUF SCALE: 1:100
 ENGINEER : ALI ABIRAM DATE ISSUED : DEC-2019
 DRAWN BY : MOHAMMED SAHIR FILE : INSTITUTE OF ISLAMIC STUDIES.dwg
 REVISION NO. :

Rimaas pvt. ltd
 11, ROBINSON ROAD
 #04-01 RIEB
 REP. OF SINGAPORE
 TEL: (65) 4347 3781
 E-MAIL: rimaas@rimaas.com

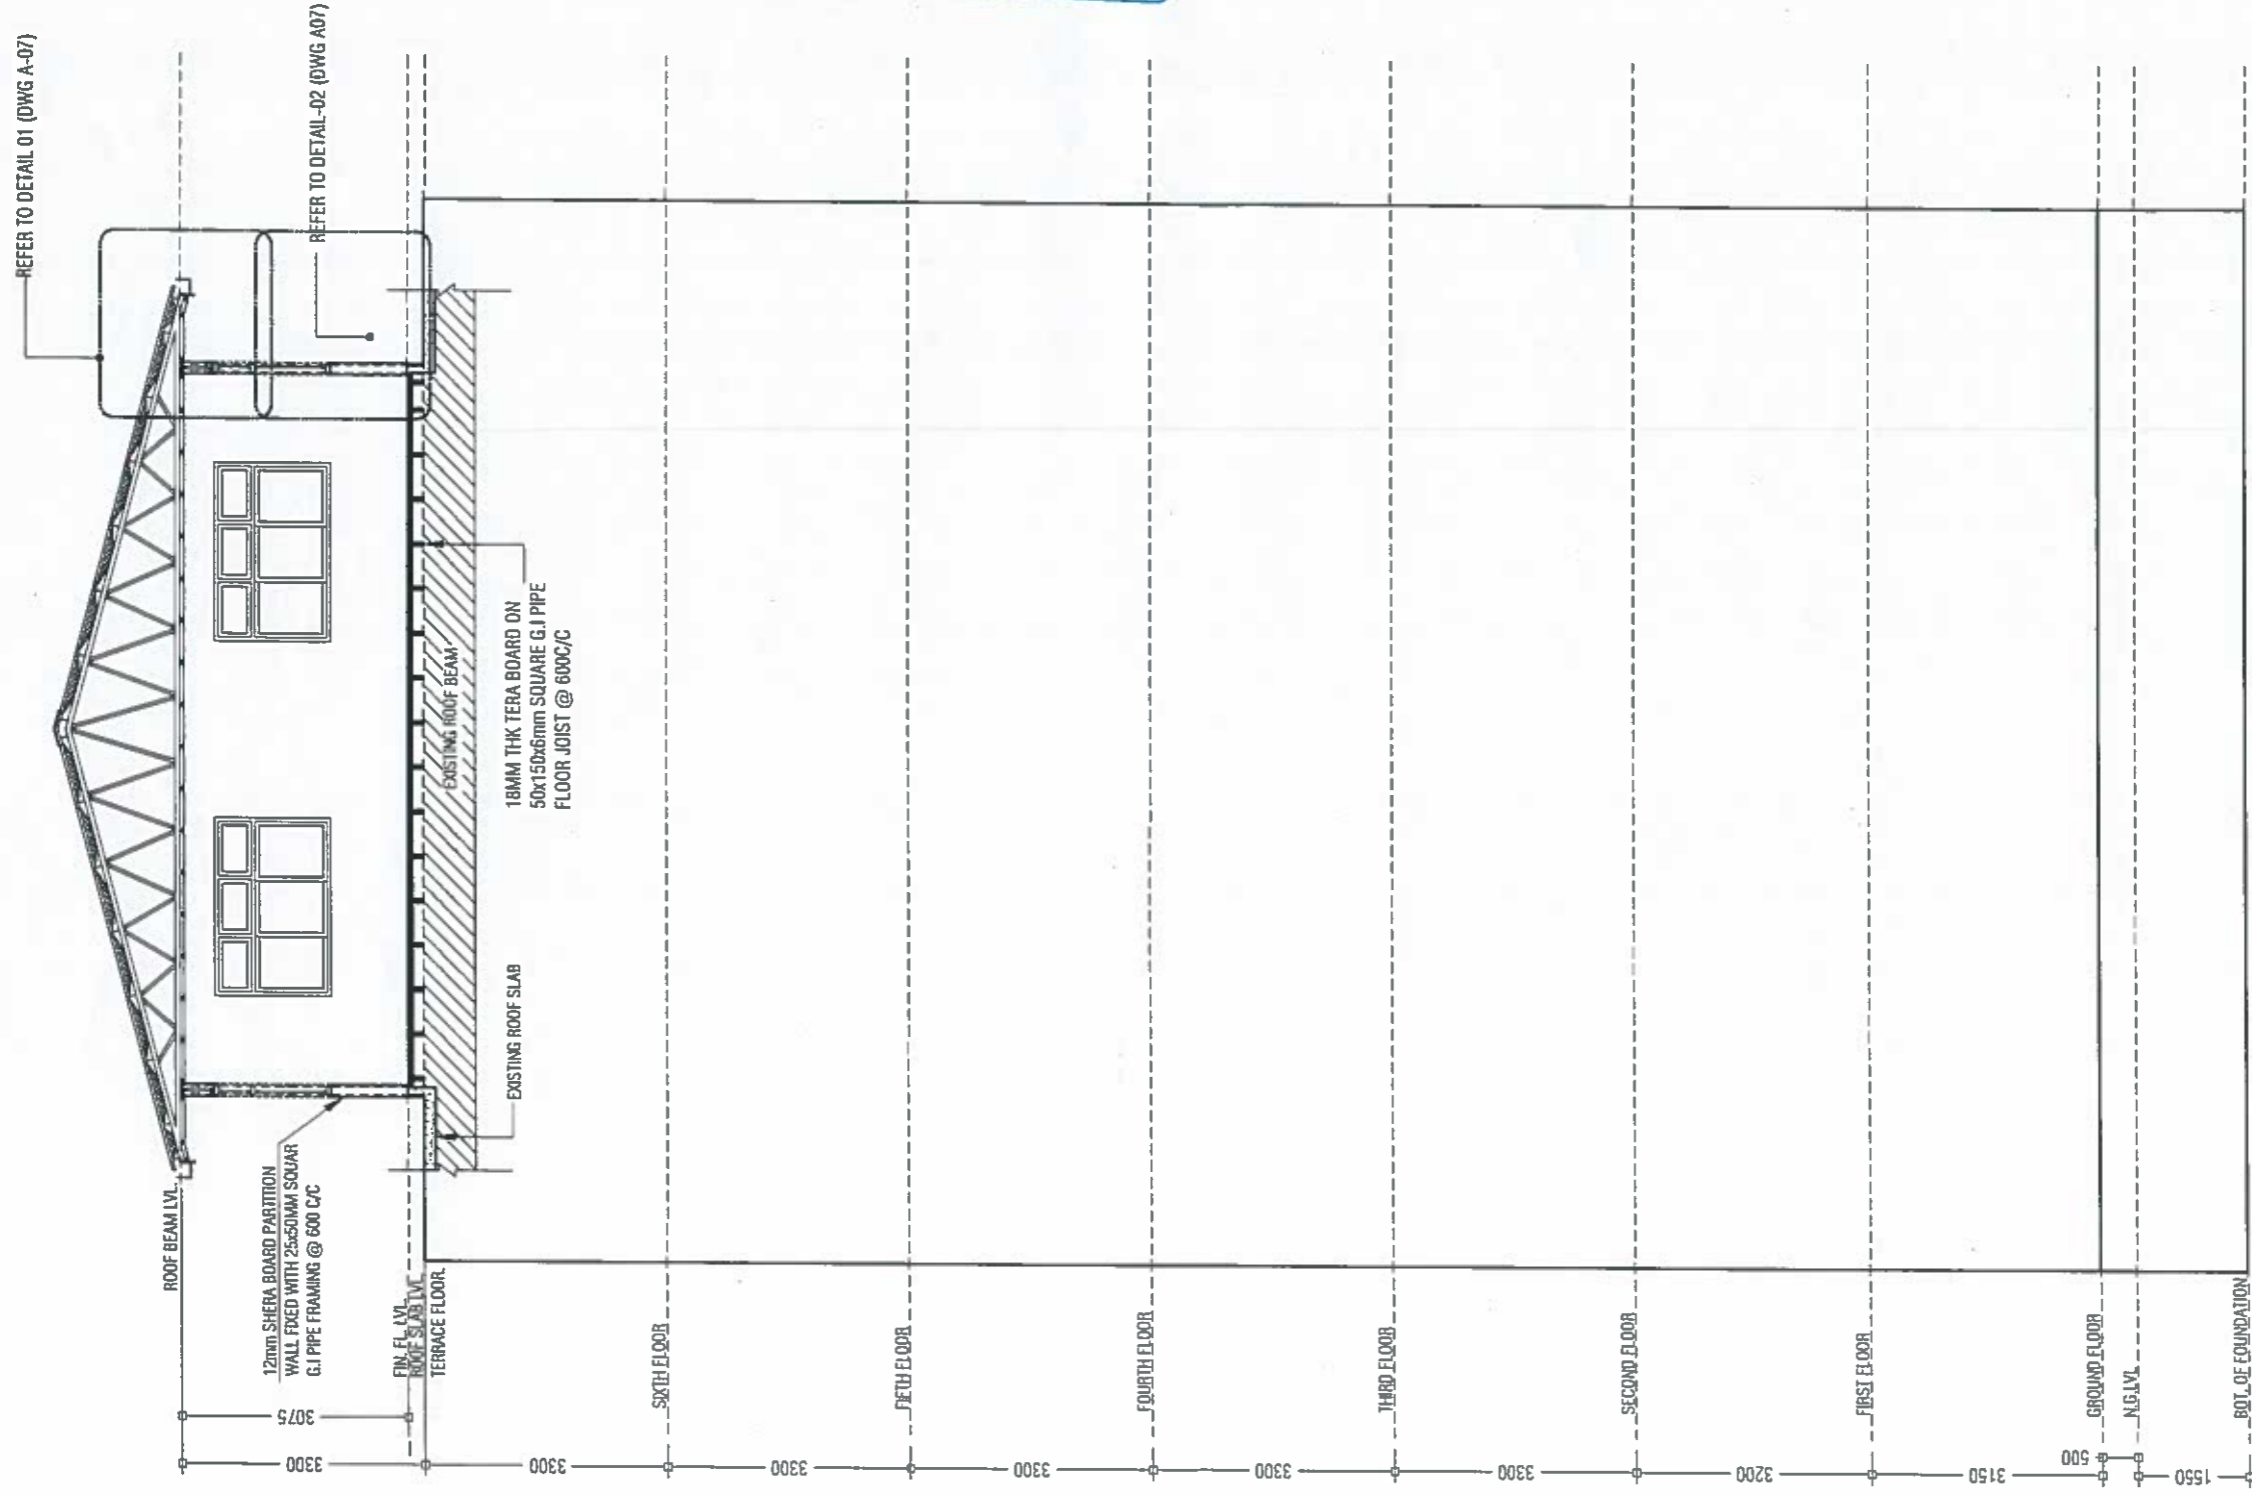

Ministry of National Planning & Infrastructure
ACCREDITED CHECKER
 ARCHITECTURAL CHECKER B1
 Name: Al Zameer
 VALUITY: 24.02.19 - 21.02.20
 Accredited No: BPR2019029B1
 B1-2019-029-001

محمد يوسف
 مهندس معماري
 مهندس معماري
 مهندس معماري

SECTION X-X
 Scale 1:100

Ministry of National Planning & Infrastructure
ACCREDITED CHECKER
 STRUCTURAL CHECKER A1
 Name: Hussain Litar
 VALUITY: 28.07.19 - 27.07.20
 Accredited No: BPR2019018A1
 A1-2019-018-001

DWG NO:
A05a

PROJECT TITLE : INSTITUTE OF ISLAMIC STUDIES - 7TH FLOOR MODIFICATION
 CLIENT : INSTITUTE OF ISLAMIC STUDIES
 SHEET CONTENTS : AS GIVEN

ARCHITECTURE: MOHAMED YOUSUF
 ENGINEER : ALI AKBAR
 DRAWN BY : MOHAMED SAMIR
 SCALE: 1:100
 DATE ISSUED : DEC-2019
 FILE : INSTITUTE OF ISLAMIC STUDIES.DWG
 REVISION NO. :


Rimaas
 pvt. ltd
 14, INDUSTRIAL GOVERNORATE
 HALL, 13, HADRA
 REG. OF ARCHITECTS
 TEL. (011) 777 7261
 E-mail: rimaas@ymail.com

SYMBOL

D1

TOTAL = 01 no.

TOTAL = 04 nos

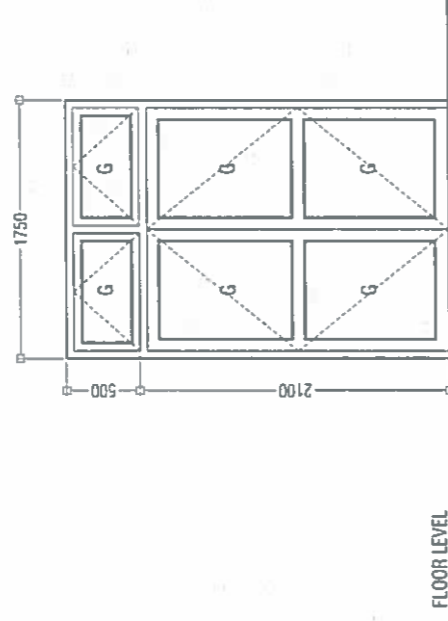

DOOR FRAME FINISHES

Powder coated aluminium frame Door

White


REMARKS

Tinted Glass

SYMBOL

W2

TOTAL = 11 nos.

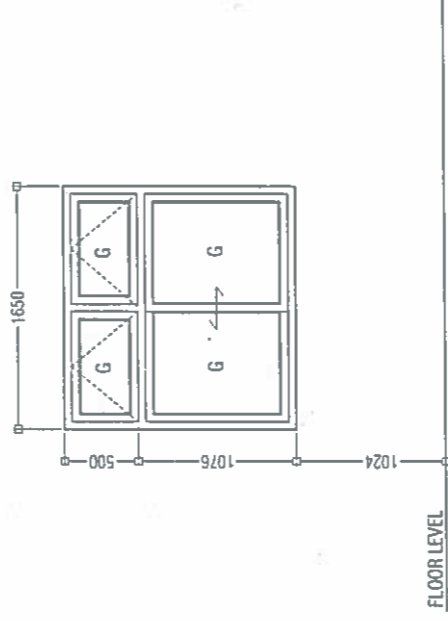

DOOR FRAME FINISHES

Powder coated aluminium frame Door

White

REMARKS

Tinted Glass

NOTES

- ALL DIMENSIONS TO BE CHECKED ON SITE PRIOR TO FABRICATION
- ALL DOOR/ WINDOWS VIEWED FROM EXTERIOR FOR THE DOOR SWING REFER TO FLOOR PLANS


- G - 6mm THK TINTED GLAZING
- T - TIMBER
- FG - 6mm THICK FIXED GLAZING

DOOR / WINDOW SCHEDULE

Scale: 1:50

Ministry of National Planning & Infrastructure
ACCREDITED CHECKER
STRUCTURAL CHECKER A1
 Name: Hussain Liar VALUITY: 28.01.19 - 27.01.20
 Accredited No: BPR2019018A1 A1-2019-018-001

Ministry of National Planning & Infrastructure
ARCHITECTURAL CHECKER
ARCHITECTURAL CHECKER B1
 Name: Al Zameer VALUITY: 24.02.19 - 23.02.20
 Accredited No: BPR2019029B1 01-2019-029-001

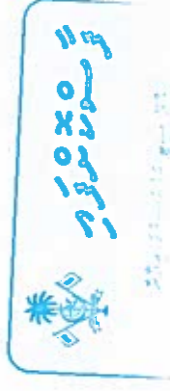

DWG NO:

A06

PROJECT TITLE : INSTITUTE OF ISLAMIC STUDIES

CLIENT : THE FLOOR ARCHITECTURE INSTITUTE OF ISLAMIC STUDIES

SHEET CONTENTS : AS GIVEN

ARCHITECTURE: MOHAMED YOUSUF

ENGINEER : HUSSAIN LIAR

DRAWN BY : MOHAMED SAHIR

SCALE: 1:50


DATE ISSUED : DEC-2019

FILE : INSTITUT OF ISLAMIC STUDIES

REVISION NO. :

REGISTERED UNDER
 REG. NO. 1000
 REP. OF SAUDI
 TEL: (966) 777 7700
 E-mail: hussain@rimaas.com


Rimaas
pvt. ltd

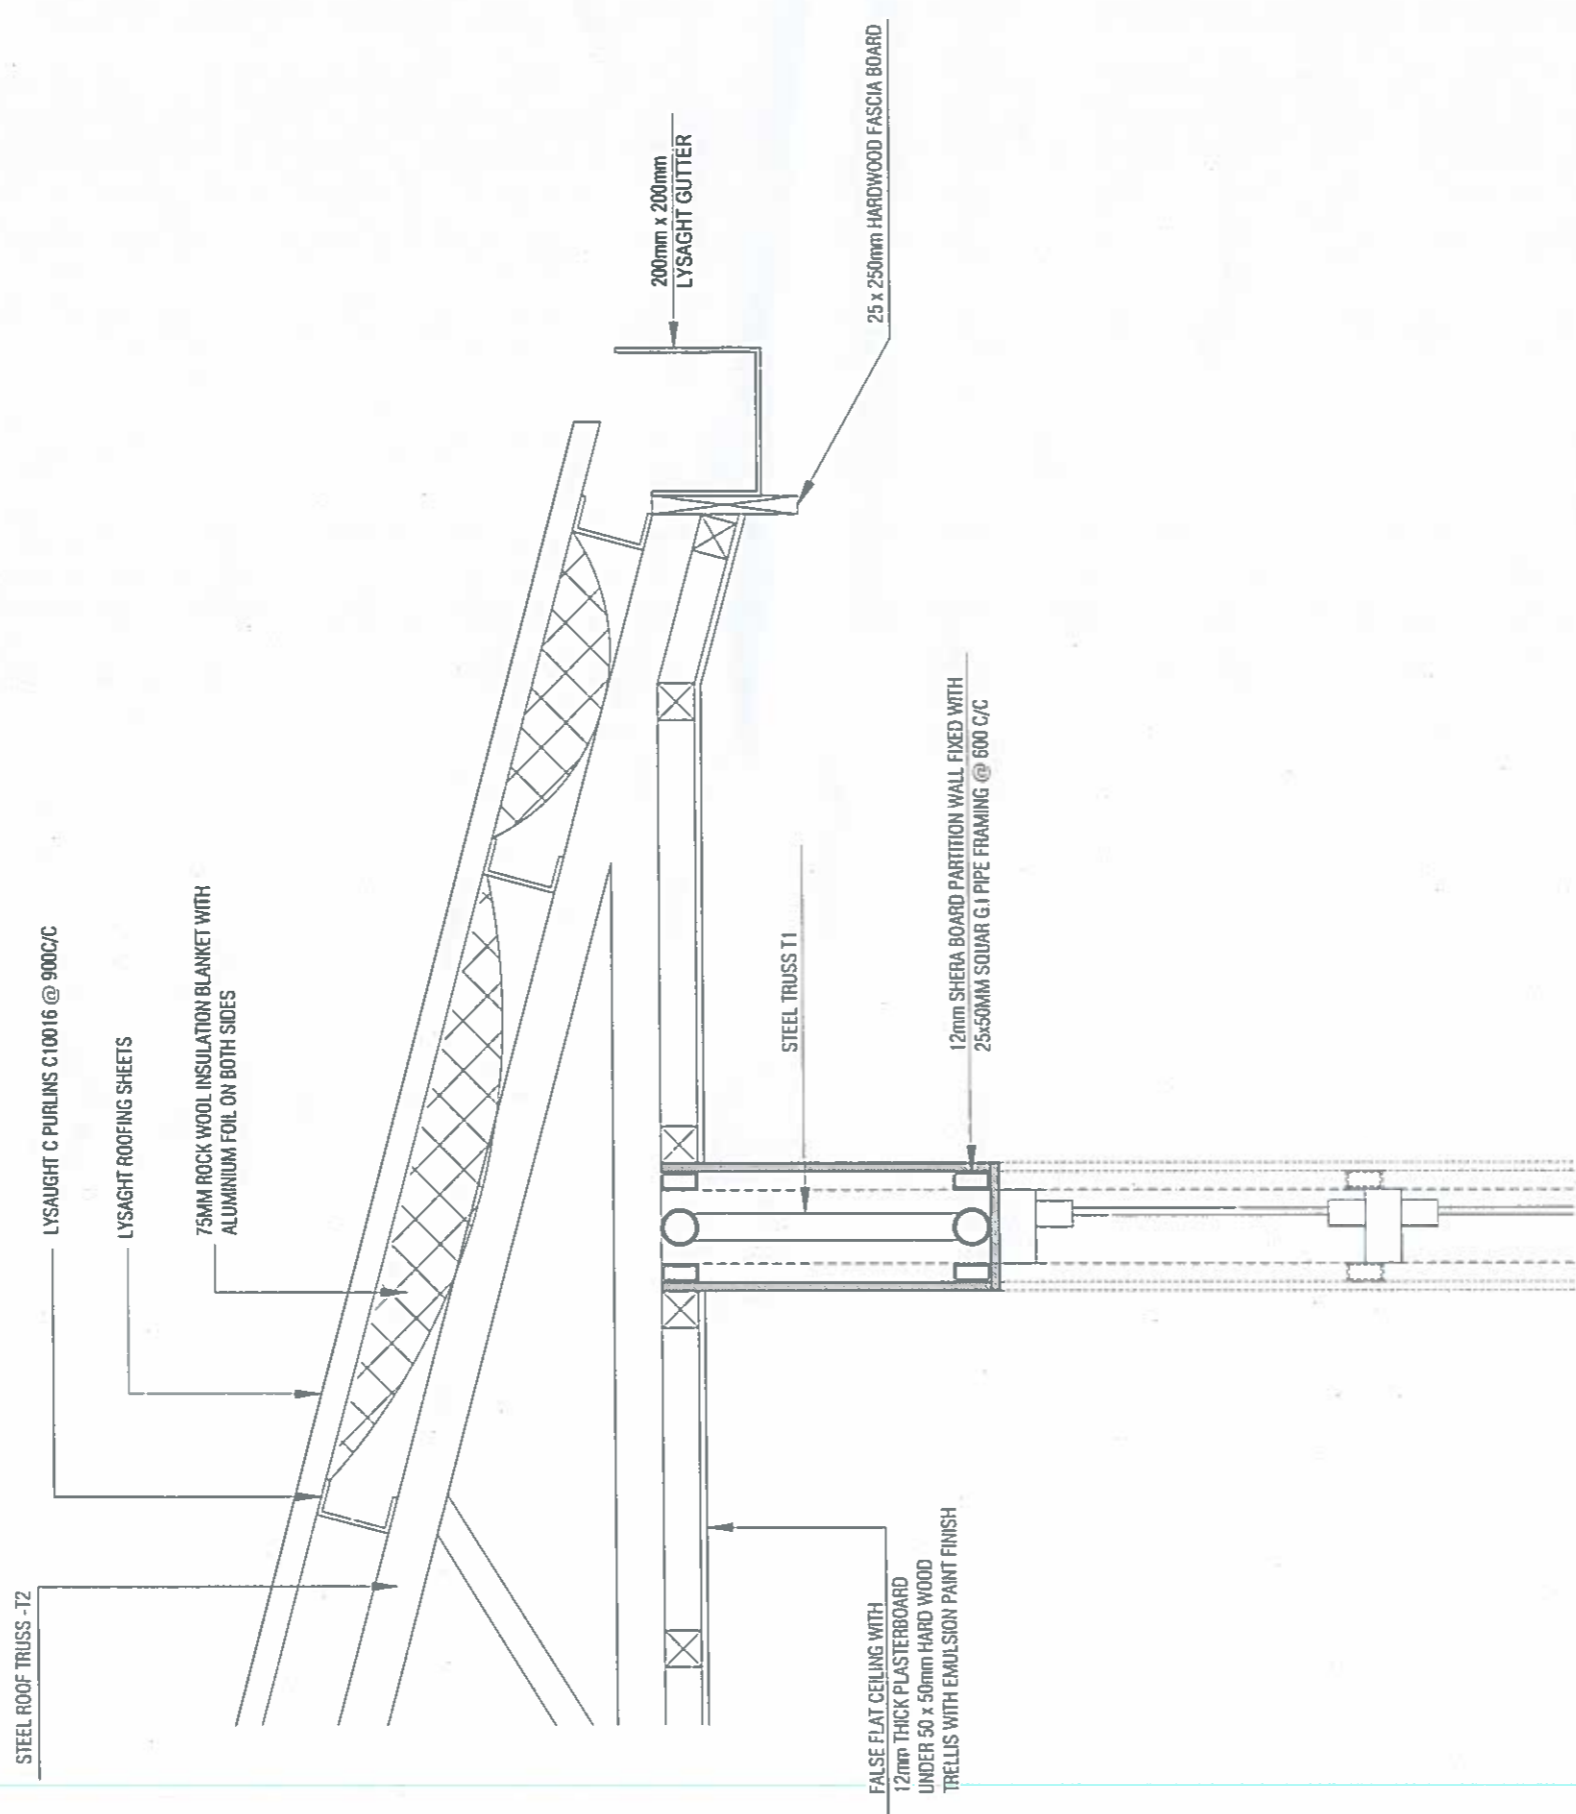

DETAIL-01
 Scale 1:10

Ministry of National Planning & Infrastructure
ACCREDITED CHECKER
STRUCTURAL CHECKER A1
 Name: Hussain Liar VALIDITY: 28.01.18 - 27.01.20
 Accredited No: BPR2019018A1 A1-2019-018-001

Ministry of National Planning & Infrastructure
ACCREDITED CHECKER
ARCHITECTURAL CHECKER B1
 Name: Ali Zameer VALIDITY: 24.02.19 - 23.02.20
 Accredited No: BPR2019029B1 B1-2019-029-001

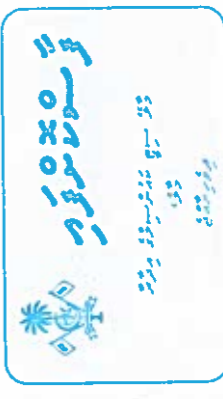


DWG NO:
A07

PROJECT TITLE :
 CLIENT :
 SHEET CONTENTS :

ARCHITECTURE: MOHAMED YOUSUF
 ENGINEER :
 DRAWN BY :
 ARCHITECTURE: MOHAMED YOUSUF
 ENGINEER :
 DRAWN BY :


Rimaas
 priv. ltd
 11, BOLDING ROAD, SINGAPORE
 110111
 REP. OF MALAYSIA
 TEL: (603) 771 7268
 e-mail: rimaas@rimaltd.com

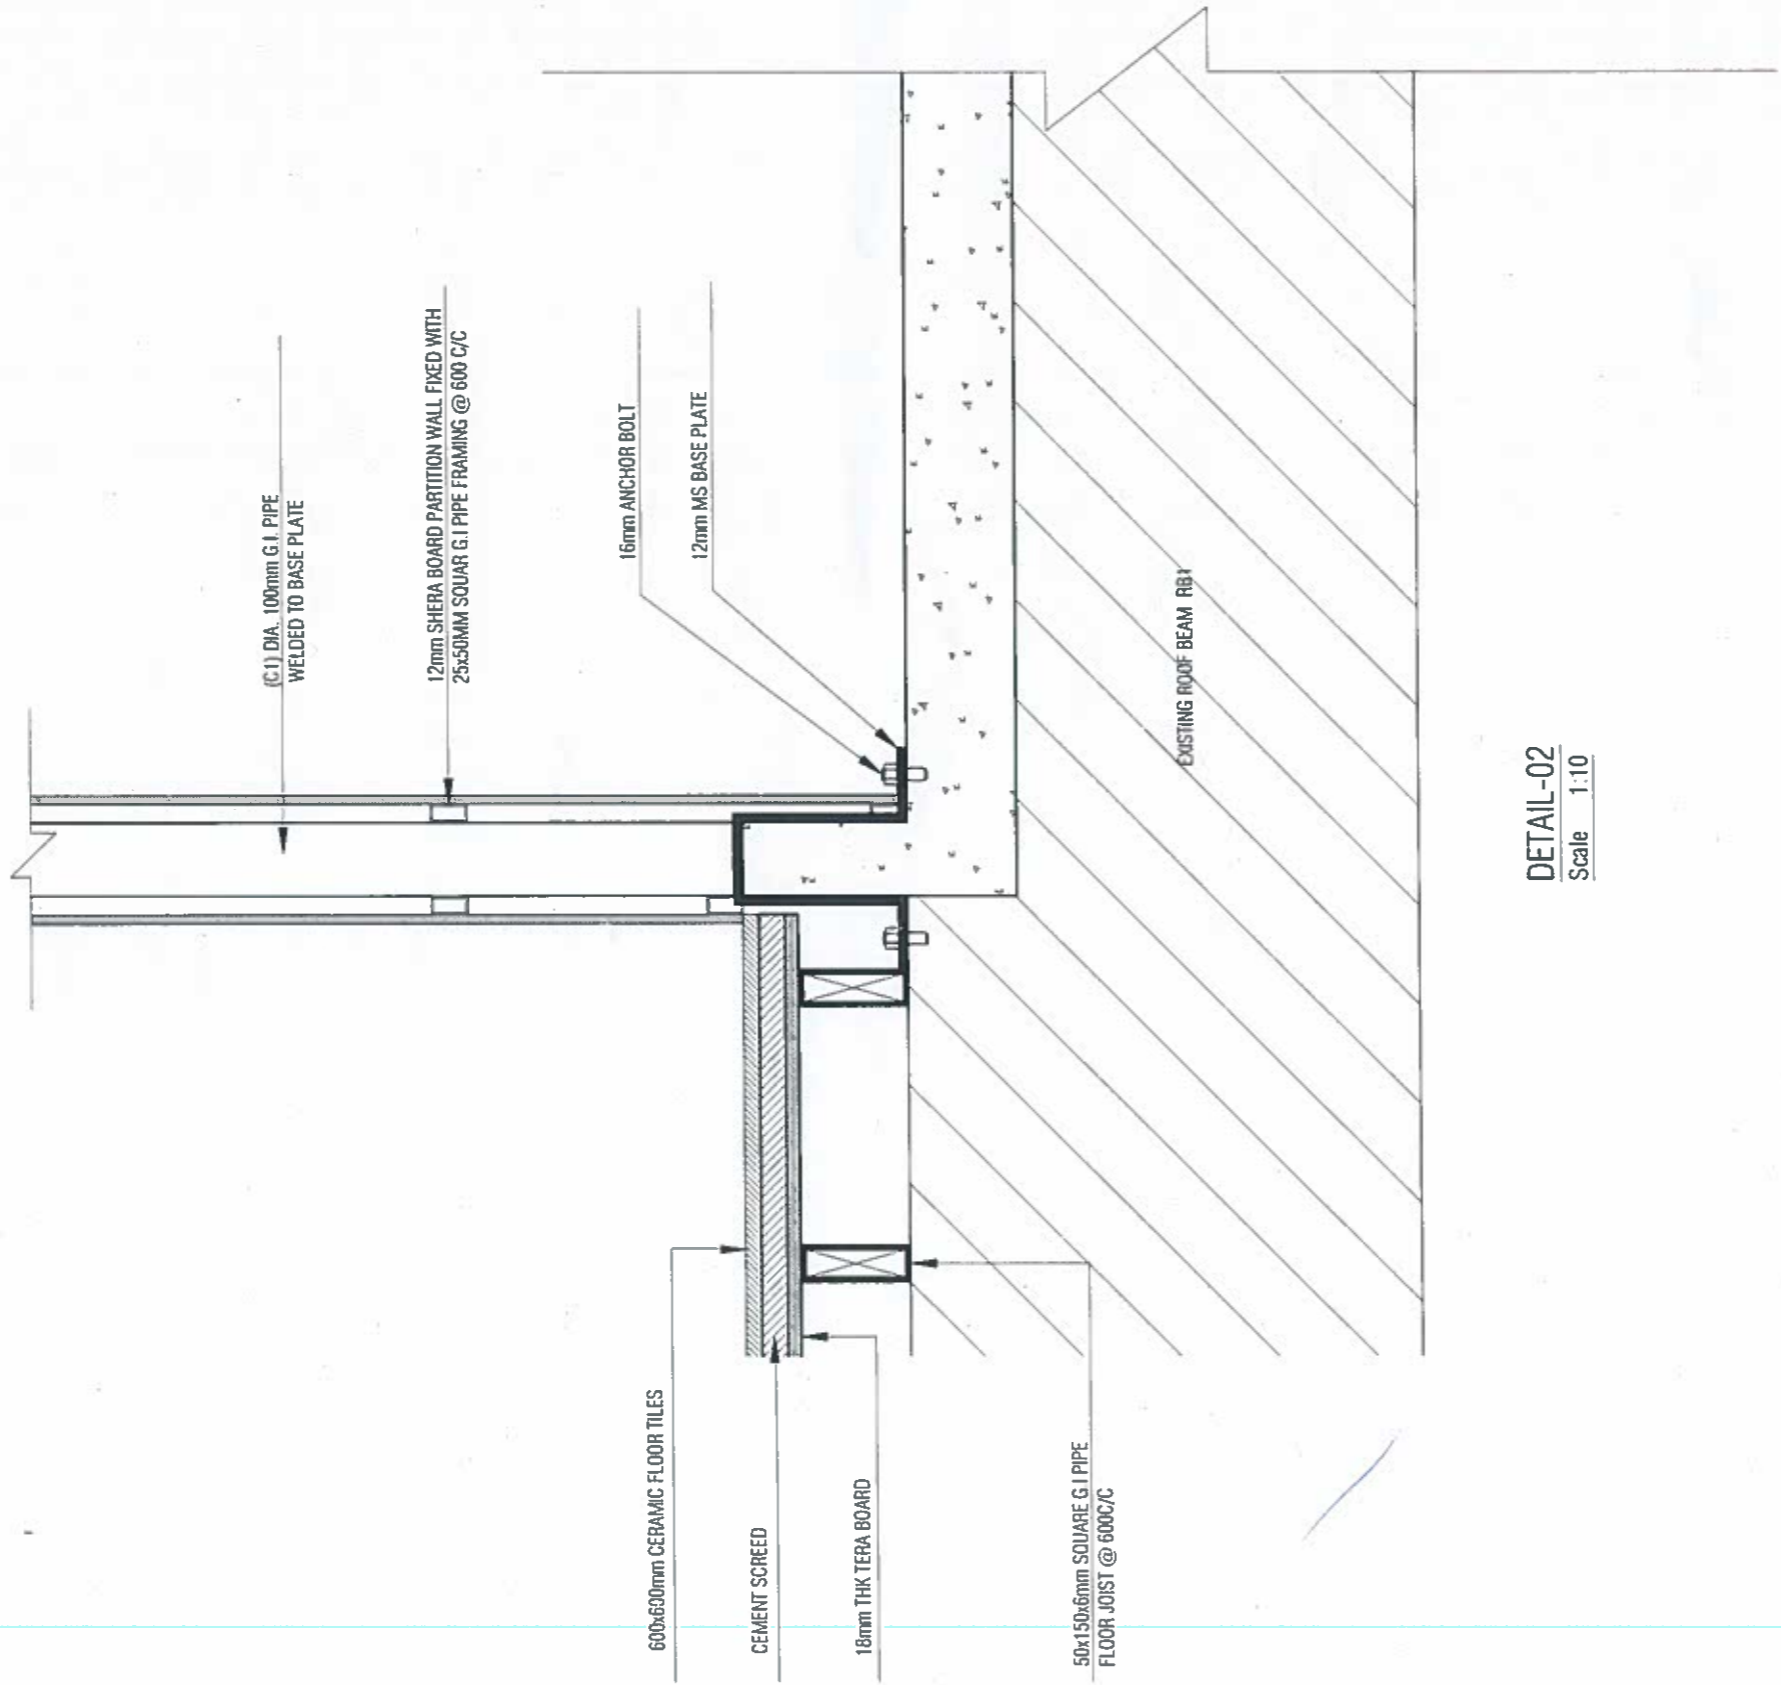

DETAIL-02
Scale 1:10


 Ministry of National Planning & Infrastructure
ACCREDITED CHECKER
STRUCTURAL CHECKER A1
 Name: Hussain Lirar VALIDITY: 28.01.19 - 27.01.20
 Accredited No: BPPR2019018A1 A1-2019-018-001


 Ministry of National Planning & Infrastructure
ACCREDITED CHECKER
ARCHITECTURAL CHECKER B1
 Name: Ali Zameer VALIDITY: 24.02.19 - 23.02.20
 Accredited No: BPPR2019029B1 B1-2019-029-001


 ريماس انجنيئرنگ
 ريماس انجنيئرنگ
 ريماس انجنيئرنگ


DWG NO:
A08

PROJECT TITLE : INSTITUTE OF ISLAMIC STUDIES
 THE FLOOR ADDIFICATION
 CLIENT : INSTITUTE OF ISLAMIC STUDIES
 SHEET CONTENTS : AS GIVEN

ARCHITECTURE: MOHAMED YOUSUF
 ENGINEER : HUSSAIN LIRAR
 DRAWN BY : MOHAMED SAMIR

SCALE: 1:10
 DATE ISSUED : DEC 2019
 FILE : ARCHITECT OF ISLAMIC STUDIES.DWG
 REVISION NO. :

Rimaas
 priv. ltd
 14 BOONMEGA LAKSHYAVILLAGE
 MAHE
 REP: IS MALDIVES
 TEL: (960) 777 7700
 e-mail: rimaas@rimaltd.com

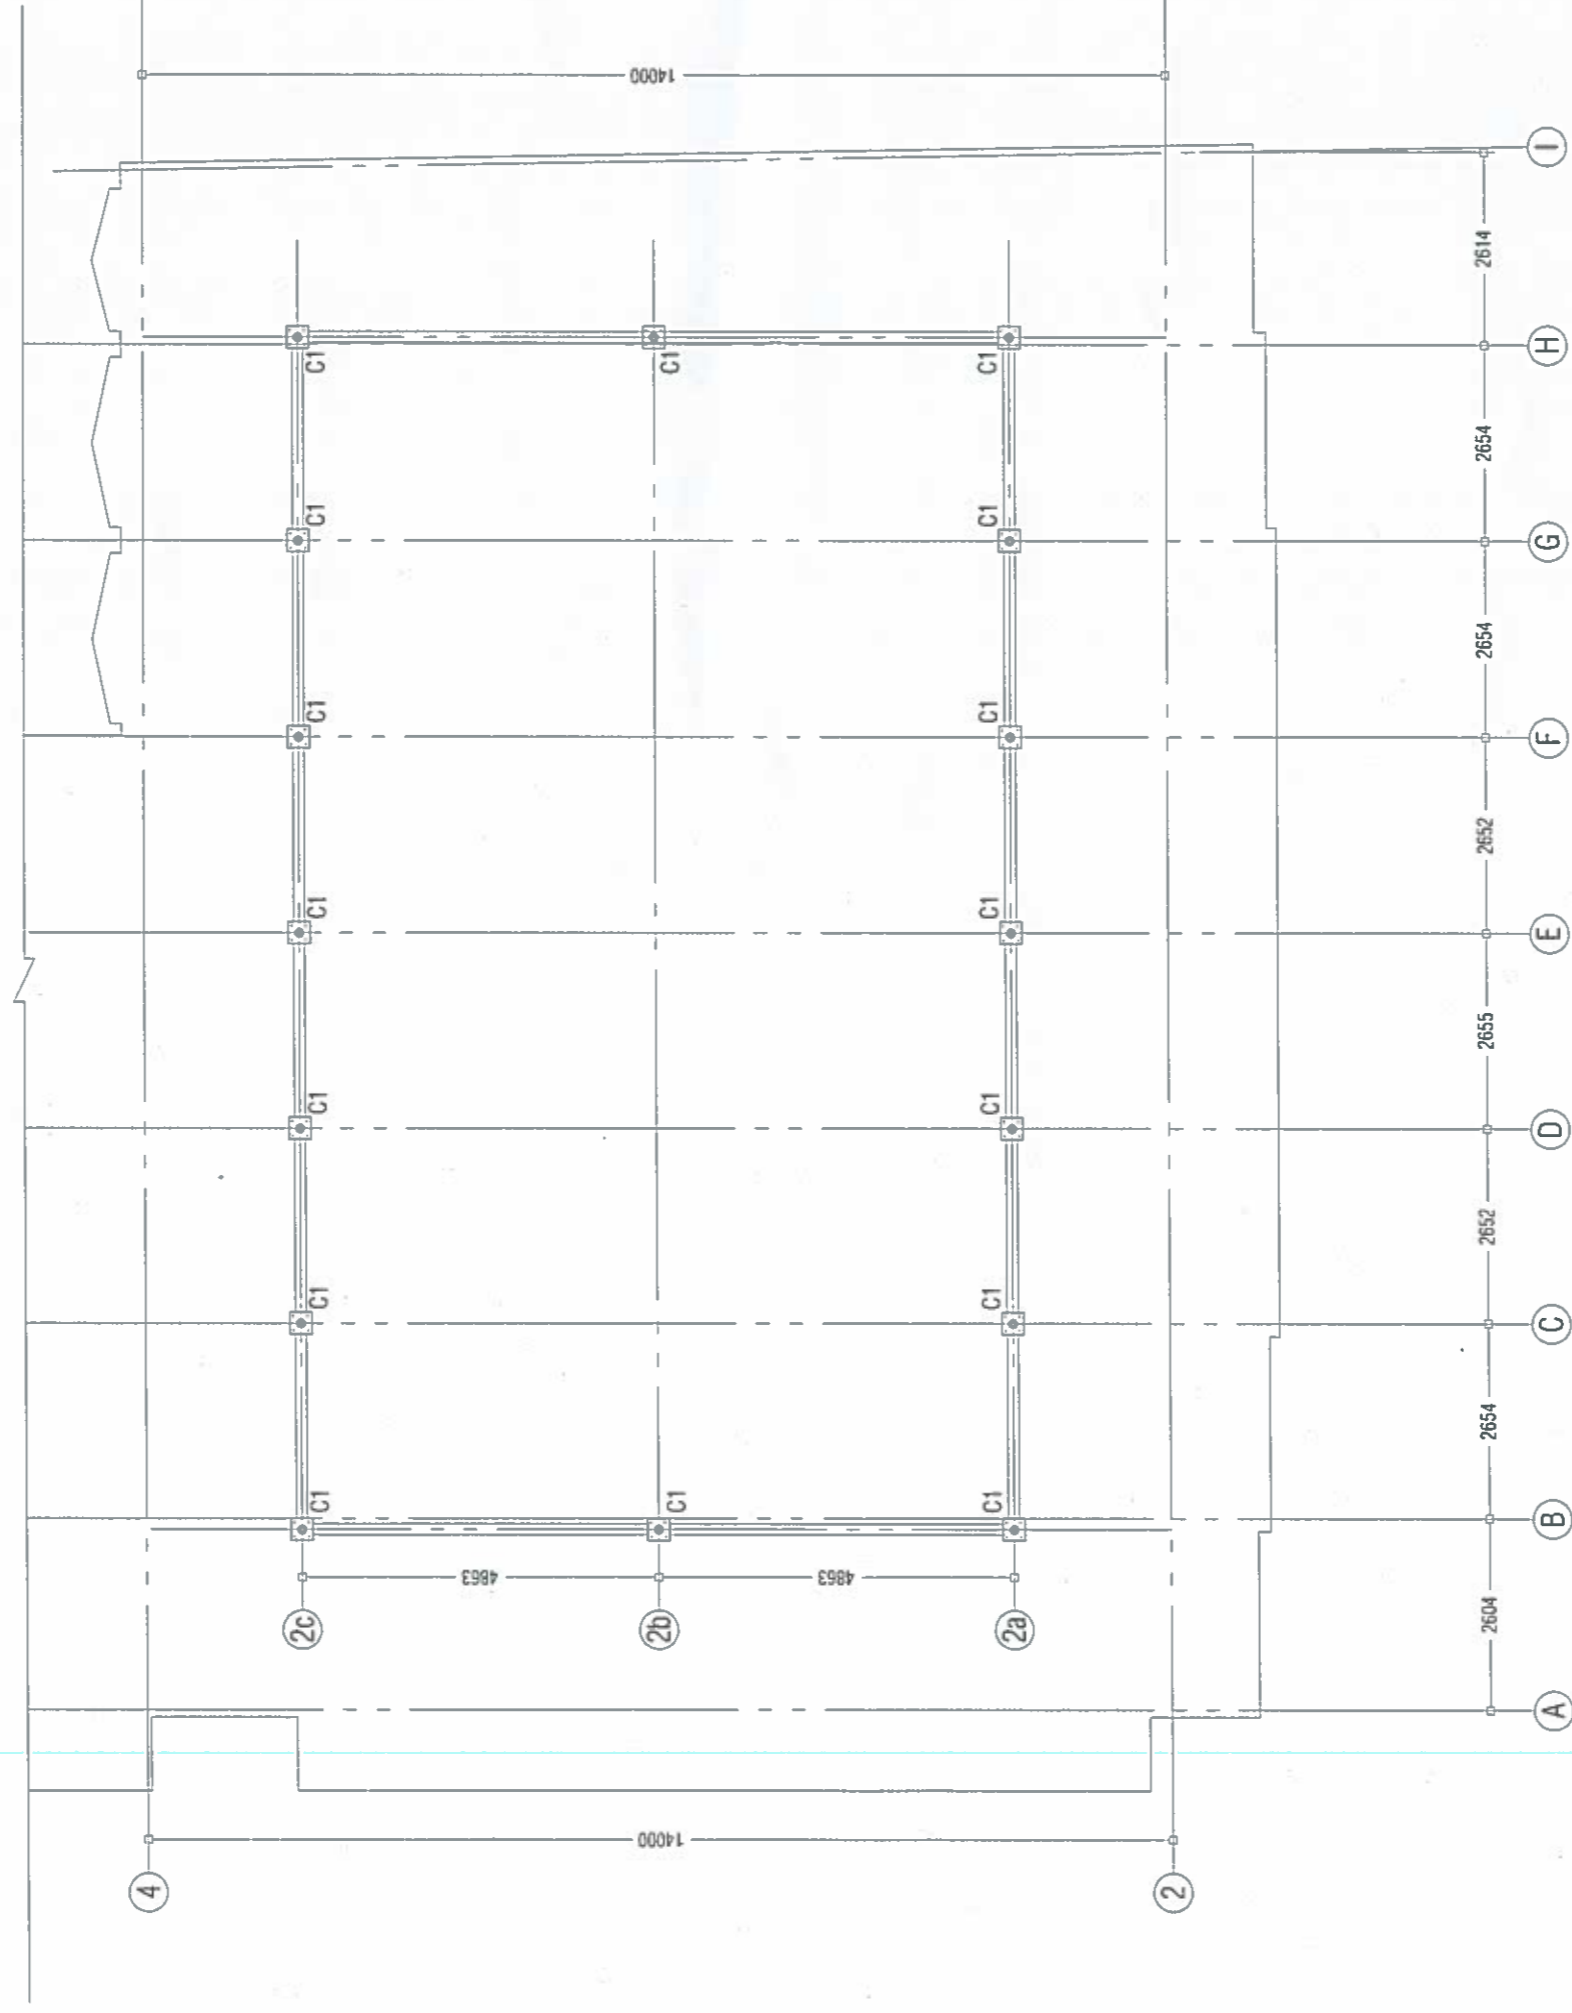


COLUMN LOCATION LAYOUT

Scale 1:100

NOTE: COLUMN (C1) FIXED TO EXISTING ROOF BEAM
REFER FIXING DETAILS DWG - E05


Ministry of National Planning & Infrastructure
ACCREDITED CHECKER
STRUCTURAL CHECKER A1
 Name: Hussain Lizar VALIDITY: 26.01.19 - 27.01.20
 Accredited No: BPR2019018A1 A1-2019-018-001


Ministry of National Planning & Infrastructure
ACCREDITED CHECKER
ARCHITECTURAL CHECKER B1
 Name: Ali Zameer VALIDITY: 24.02.19 - 23.02.20
 Accredited No: BPR2019029B1 B1-2019-029-001


Ministry of National Planning & Infrastructure
ACCREDITED CHECKER
ARCHITECTURAL CHECKER B1
 Name: Ali Zameer VALIDITY: 24.02.19 - 23.02.20
 Accredited No: BPR2019029B1 B1-2019-029-001

DWG NO:
E01

PROJECT TITLE :
INSTITUTE OF ISLAMIC STUDIES
TELECOM ABBOTTABAD
INSTITUTE OF ISLAMIC STUDIES

CLIENT :

SHEET CONTENTS : AS GIVEN


ARCHITECTURE: MOHAMED YOUSUF
ENGINEER : ALI ANGRAH

SCALE: 1:100 DATE ISSUED : DEC. 2019

FILE : INSTITUTE OF ISLAMIC STUDIES

DRAWN BY : MOHAMED SAMIR REVISION NO. :


Rimaas
 pvt. ltd
 IS REGULATED UNDER THE
 MALDIVES MALDIVE MALDIVE
 REP. OF MALDIVES
 TEL: (960) 771 7760
 E-mail: rimaas@rimaltd.com

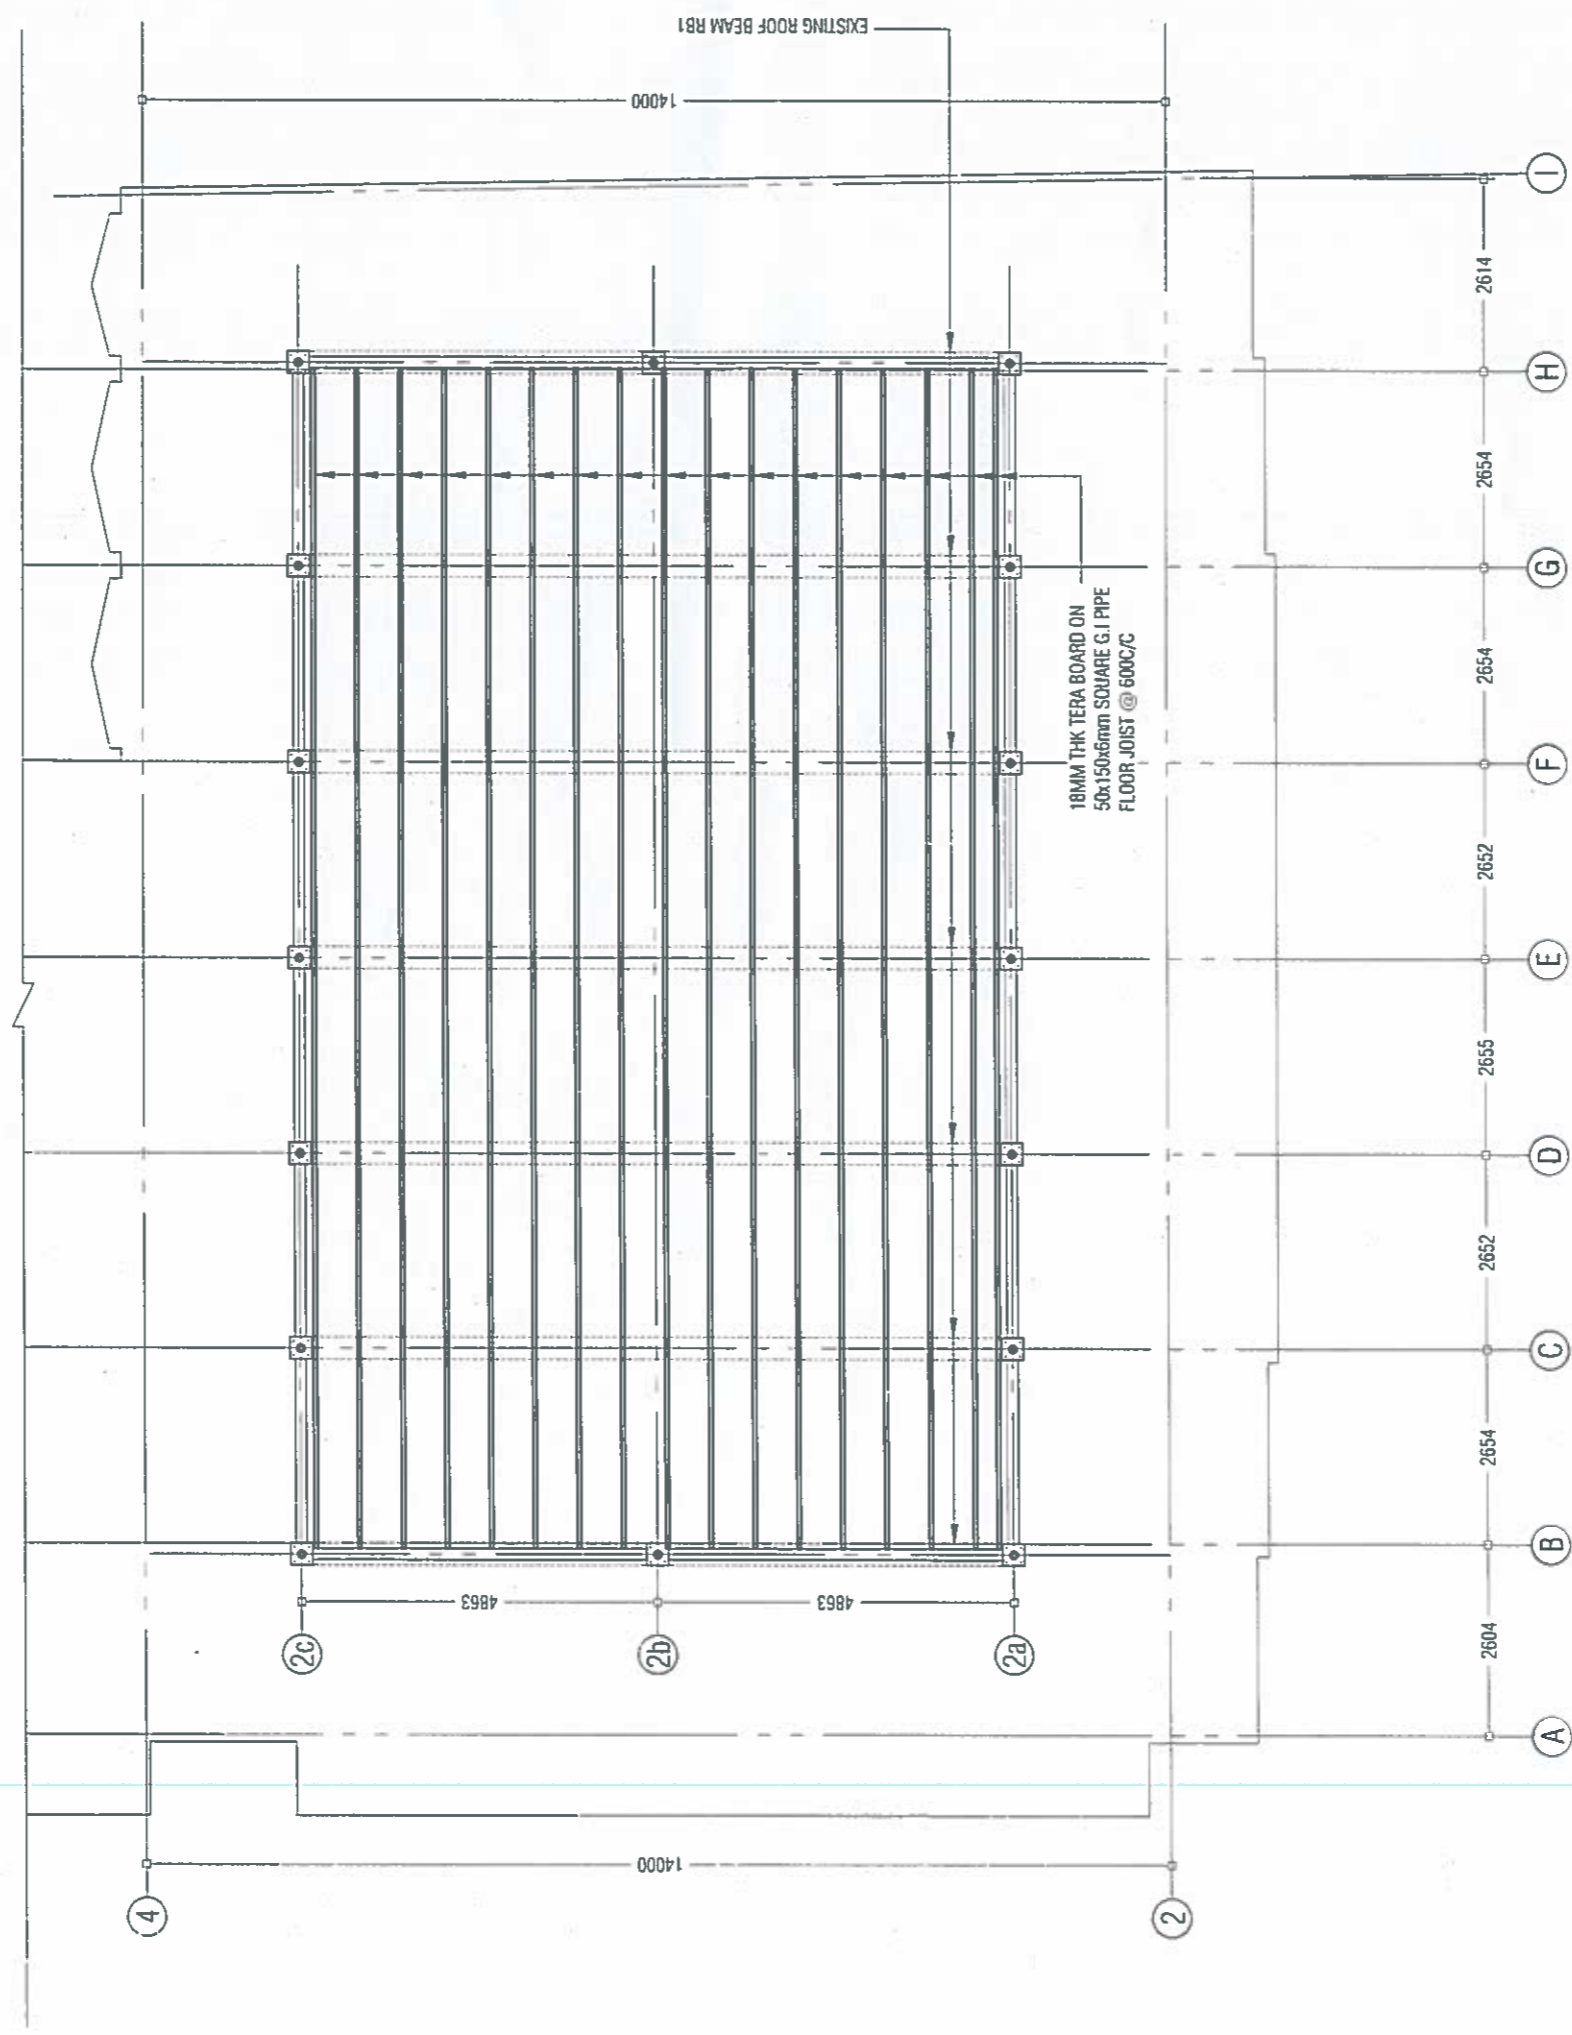


7TH (TERRACE) FLOOR DECKING LAYOUT

Scale: 1:100


Ministry of National Planning & Infrastructure
ACCREDITED CHECKER
STRUCTURAL CHECKER A1
 Name: Hussain Lizar Validity: 26.01.19 - 27.01.20
 Accredited No: BPR2019018A1 A1-2019-018-001


ACCREDITED CHECKER
ARCHITECTURAL CHECKER B1
 Name: Ali Zameer Validity: 24.02.19 - 23.02.20
 Accredited No: BPR201902981 B1-2019-029-001


ACCREDITED CHECKER
MECHANICAL CHECKER
 Name: Mohamed Samir Validity: 24.02.19 - 23.02.20
 Accredited No: BPR201902981 B1-2019-029-001

DWG NO: E02

PROJECT TITLE : INSTITUTE OF ISLAMIC STUDIES
 7TH FLOOR ADDITION
 CLIENT : INSTITUTE OF ISLAMIC STUDIES
 SHEET CONTENTS : AS GIVEN

ARCHITECTURE: MOHAMED YOUSUF
 ENGINEER : ALI ANRAM
 DRAWN BY : MOHAMED SAMIR
 SCALE: 1:100
 DATE ISSUED : DEC. 2019
 FILE : INSTITUTE OF ISLAMIC STUDIES.DWG
 REVISION NO. :

Rimaas
 pvt. ltd
 14, BLOKONGA, LIDGESVILLE
 11500, JOHANNESBURG
 REP. OF SALES
 TEL: (011) 771 7700
 e-mail: rimaas@rmaas.com




ROOF BEAM TRUSS PLAN

Scale 1:100


Ministry of National Planning & Infrastructure
ACCREDITED CHECKER
STRUCTURAL CHECKER A1
 Name: Hussain Lizar VALIDITY: 28.01.19 - 27.01.20
 Accredited No: BPR2019018A1 A1-2019-018-001


Ministry of National Planning & Infrastructure
ACCREDITED CHECKER
ARCHITECTURAL CHECKER B1
 Name: Ali Zameer VALIDITY: 24.02.19 - 23.02.20
 Accredited No: BPR2019029B1 B1-2019-029-001



Ministry of National Planning & Infrastructure
ACCREDITED CHECKER
ARCHITECTURAL CHECKER B1
 Name: Ali Zameer VALIDITY: 24.02.19 - 23.02.20
 Accredited No: BPR2019029B1 B1-2019-029-001

DWG NO: E03

PROJECT TITLE : INSTITUTE OF ISLAMIC STUDIES - 7TH FLOOR MODIFICATION
 CLIENT : INSTITUTE OF ISLAMIC STUDIES
 SHEET CONTENTS : AS GIVEN

ARCHITECTURE: MOHAMED YOUSUF
 ENGINEER : ALI ANRAM
 DRAWN BY : MOHAMED SAMIR
 SCALE: 1:100
 DATE ISSUED : DEC-2019
 FILE : PROJECT OF ISLAMIC STUDIES.rvt
 REVISION NO. :

Rimaas pvt. ltd
 INSTITUTE OF ISLAMIC STUDIES
 7TH FLOOR MODIFICATION
 REP. OF SAUDI ARABIA
 TEL: (966) 117 7781
 E-mail: rimaas@rmaas.com

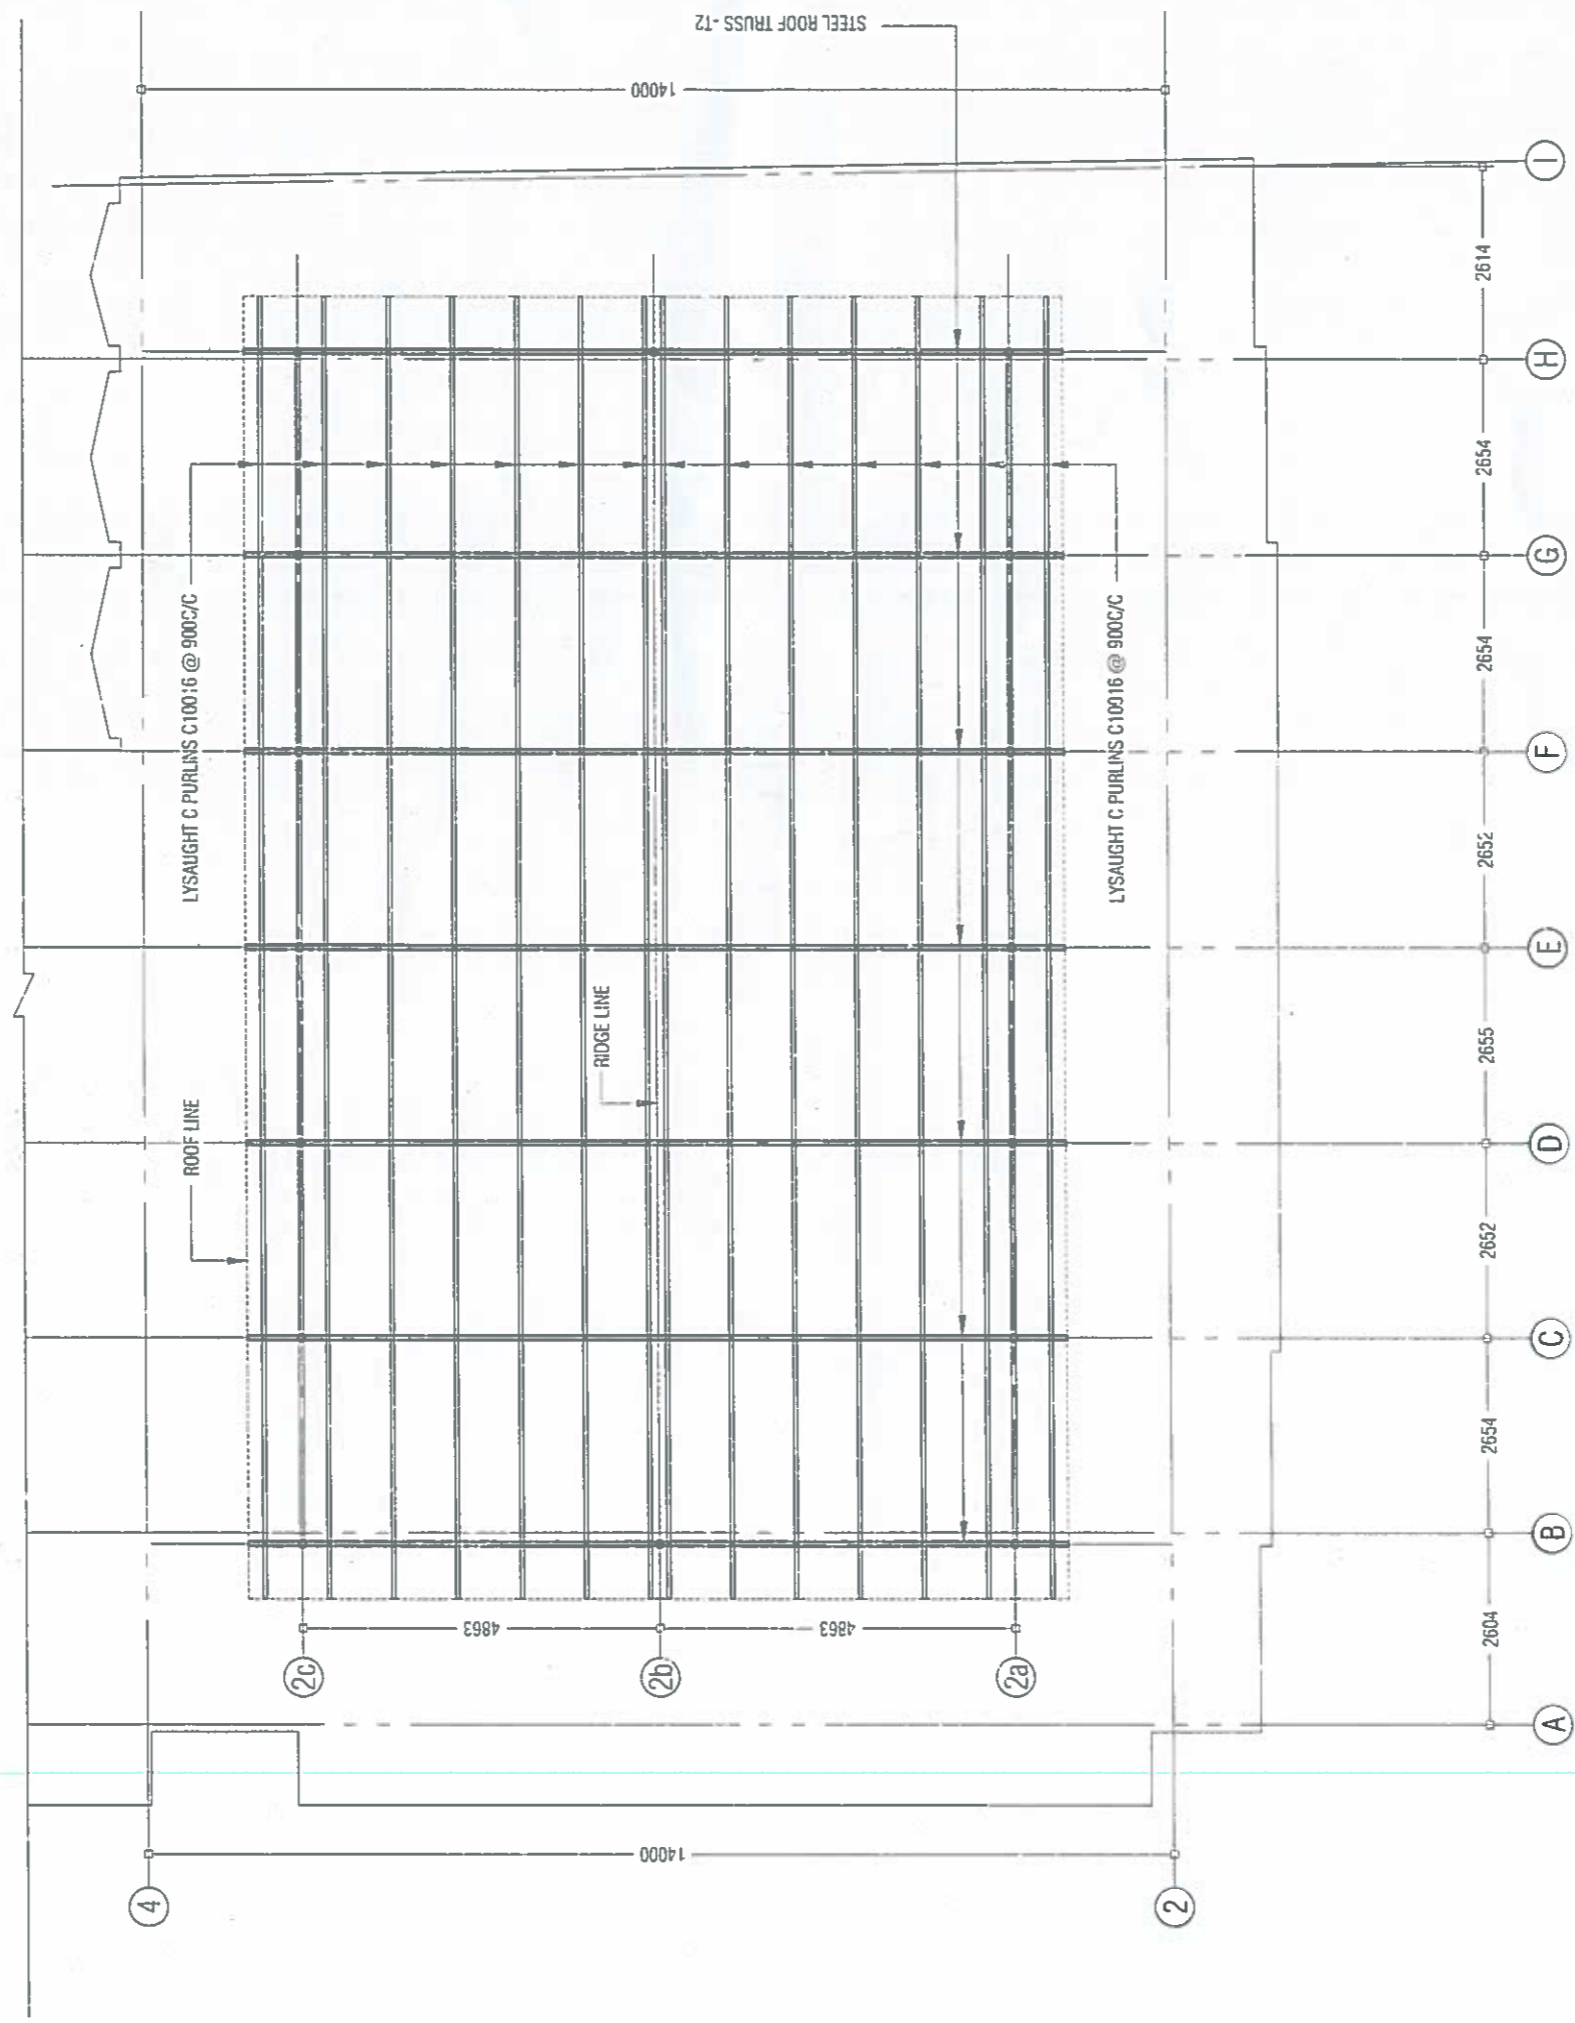

ROOF FRAMING PLAN
Scale 1:100


Ministry of National Planning & Infrastructure
ACCREDITED CHECKER
STRUCTURAL CHECKER A1
 Name: Hussain Lizar VALIDITY: 26.01.19 - 27.01.20
 Accredited No: BPR2019018A1 A1-2019-018-001

Ministry of National Planning & Infrastructure
ACCREDITED CHECKER
ARCHITECTURAL CHECKER B1
 Name: Ali Zameer VALIDITY: 24.02.19 - 23.02.20
 Accredited No: BPR2019029B1 B1-2019-029-001


DWG NO:
E04

PROJECT TITLE: **INSTITUTE OF ISLAMIC STUDIES - THE FLOOR AREA PLAN**
 CLIENT: **INSTITUTE OF ISLAMIC STUDIES**
 SHEET CONTENTS: AS GIVEN


ARCHITECTURE: MOHAMED YOUSUF SCALE: 1:100
 ENGINEER: ALI ANRAM DATE ISSUED: DEC-2019
 DRAWN BY: MOHAMED SAMIR FILE: MINISTRY OF ISLAMIC STUDIES
 REVISION NO.:

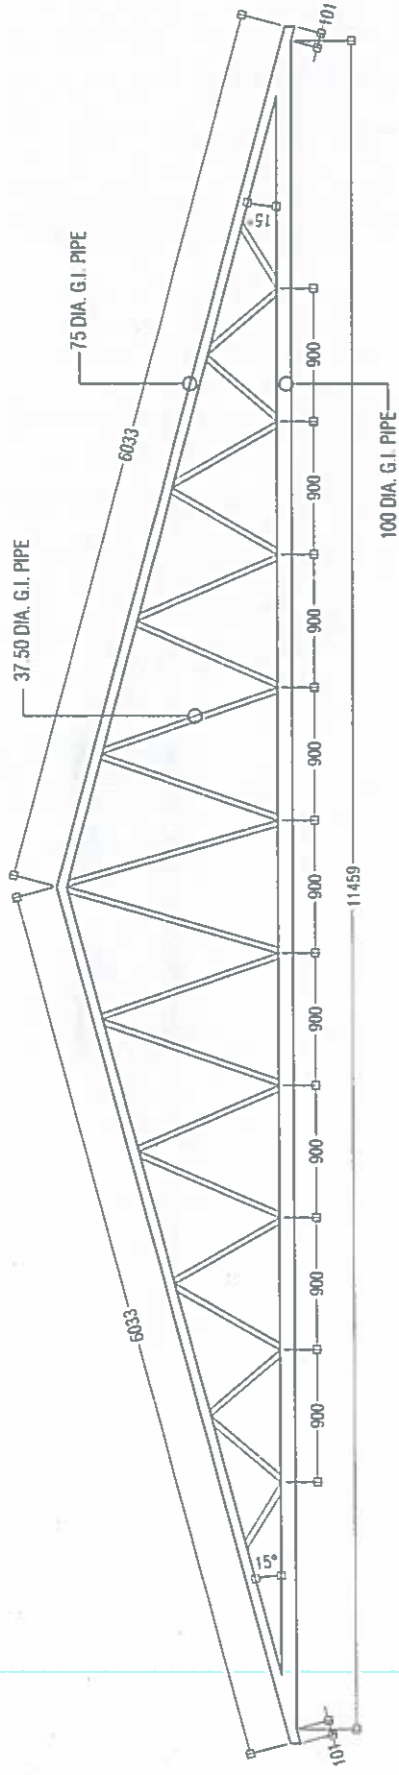

STEEL ROOF TRUSS -T2
Scale: 1:50

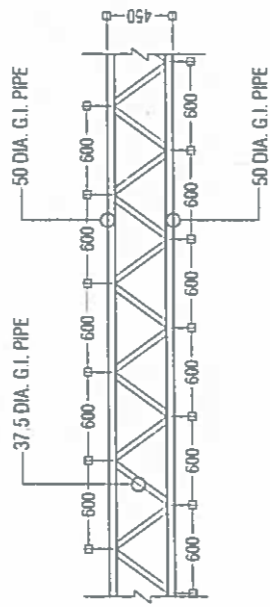

STEEL TRUSS -T1
Scale: 1:50

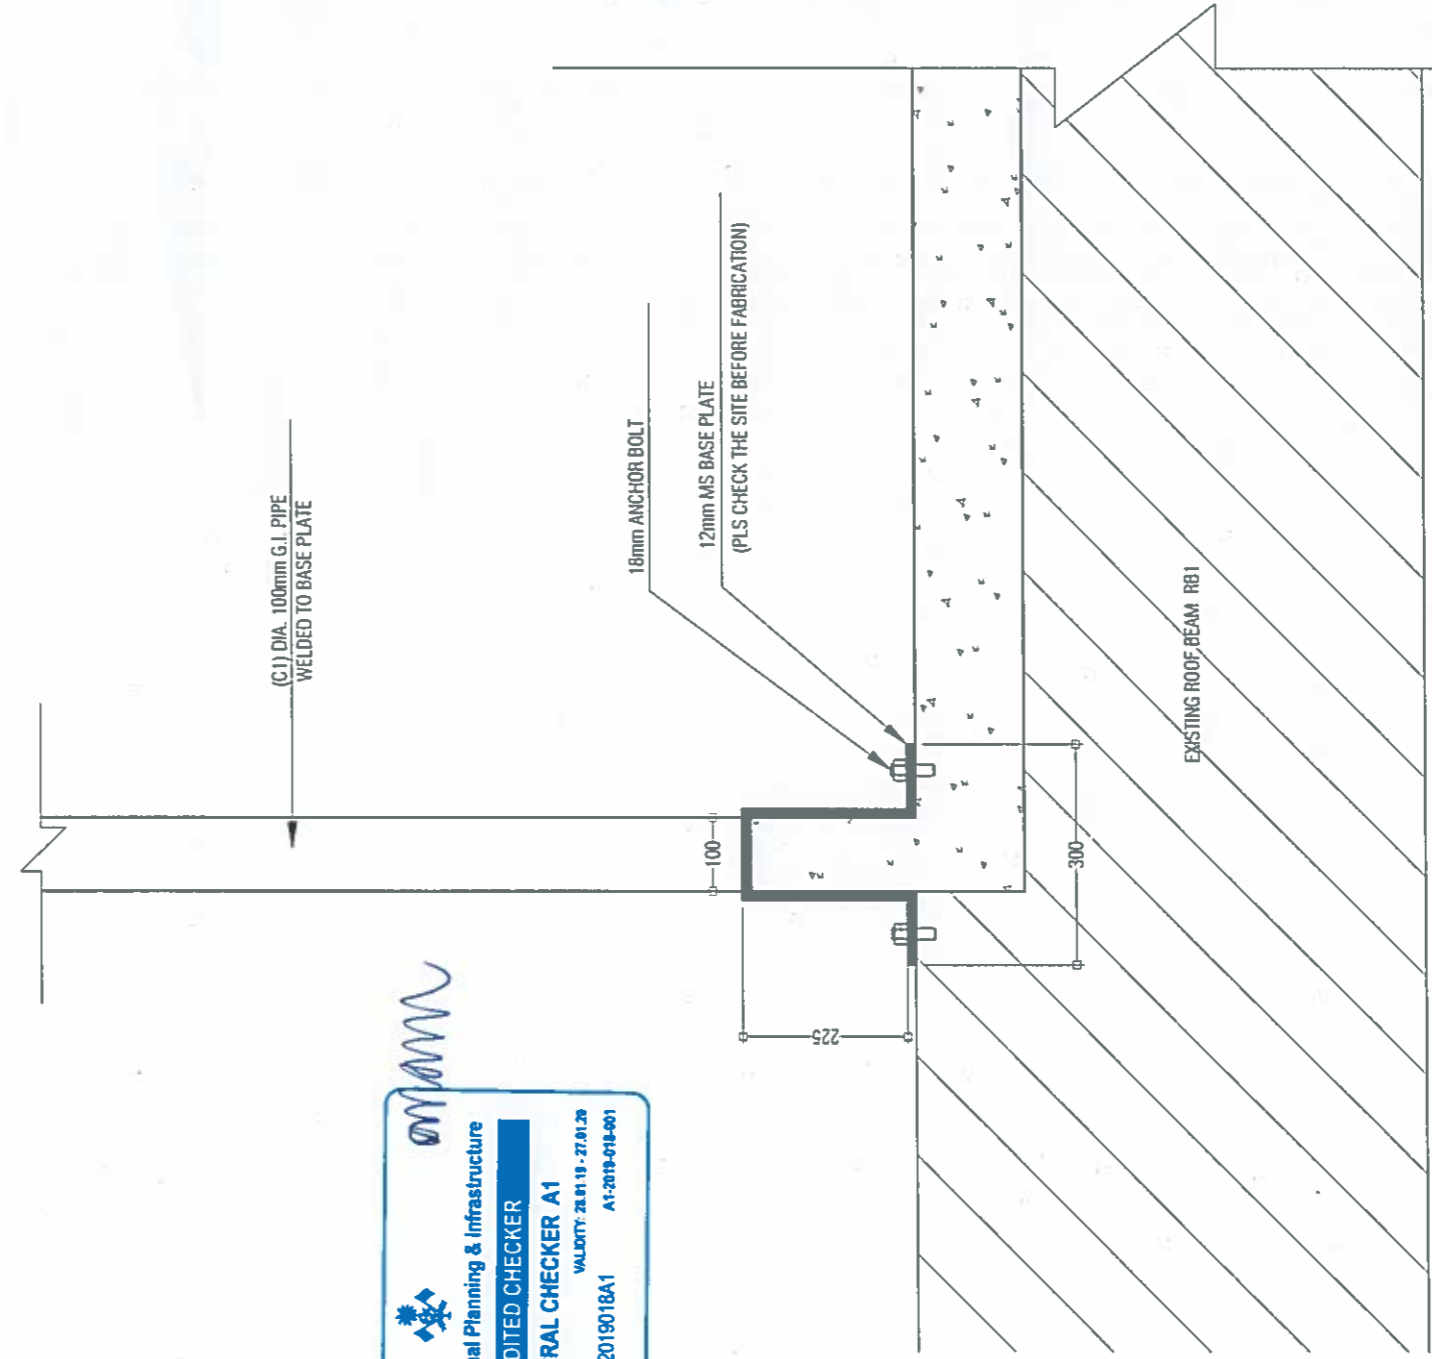

C1 FIXING DETAILS
Scale: 1:10


 Ministry of National Planning & Infrastructure
ACCREDITED CHECKER
STRUCTURAL CHECKER A1
 Name: Hussain Lirar VALIDITY: 28.01.19 - 27.01.20
 Accredited No: BPR2019018A1 AT-2019-018-001


 Ministry of National Planning & Infrastructure
ACCREDITED CHECKER
ARCHITECTURAL CHECKER B1
 Name: Ali Zameer VALIDITY: 24.02.19 - 23.02.20
 Accredited No: BPR2019029B1 B1-2019-029-001



DWG NO:
E05

PROJECT TITLE : INSTITUTE OF ISLAMIC STUDIES - ZILFLOOR ADDITION
 CLIENT : INSTITUTE OF ISLAMIC STUDIES
 SHEET CONTENTS : AS GIVEN

ARCHITECTURE: MOHAMED YOUSUF
 ENGINEER : HUSSAIN LIRAR
 DRAWN BY : MOHAMED SAMIR


Rimaas
 priv. Ltd
 MIDDLE EAST OFFICE
 FLOOR 1100
 REP. OF SAUDI ARABIA
 P.O. BOX 11777
 JEDDAH, SAUDI ARABIA
 E-MAIL: info@rimaas.com

SCALE: 1:50
 DATE ISSUED : DEC-2019
 FILE : INSTITUTE OF ISLAMIC STUDIES.dwg
 REVISION NO. :

LEGEND:

SYMBOL	DESCRIPTION	SYMBOL	DESCRIPTION
	DISTRIBUTION BOARD		FAN/DIMMER
	1x2 SOCKET OUTLET 13AMP		CEILING RECESSED LIGHTS DIA 150MM
	1x1 SOCKET OUTLET 15 AMP (FOR AIRCONDITION)		OUTDOOR CEILING MOUNT LIGHT
	1x1 SOCKET OUTLET 15 AMP (FOR EMERGENCY LIGHT)		EMERGENCY LIGHT (WALL MOUNT)
	TV POINT		1x3 SWITCH (3 GANG)
	NETWORK POINT		1x4 SWITCH (4 GANG)
	TELEPHONE POINT		A/C INDOOR WALL UNITS (24000 BTU)
	CEILING FAN		

NOTE:
 ALL WIRING TO BE OF STELCO APPROVED STANDARDS
 FLOOR LEVEL SOCKETS = 300MM FROM FLOOR FIN. LEVEL.
 ALL SWITCHES AND FAN DIMMER = 1200MM FROM FLOOR FIN. LEVEL.
 A/C / WH / EM / WP SOCKETS = 2500MM - 2700MM FROM FLOOR FIN. LEVEL

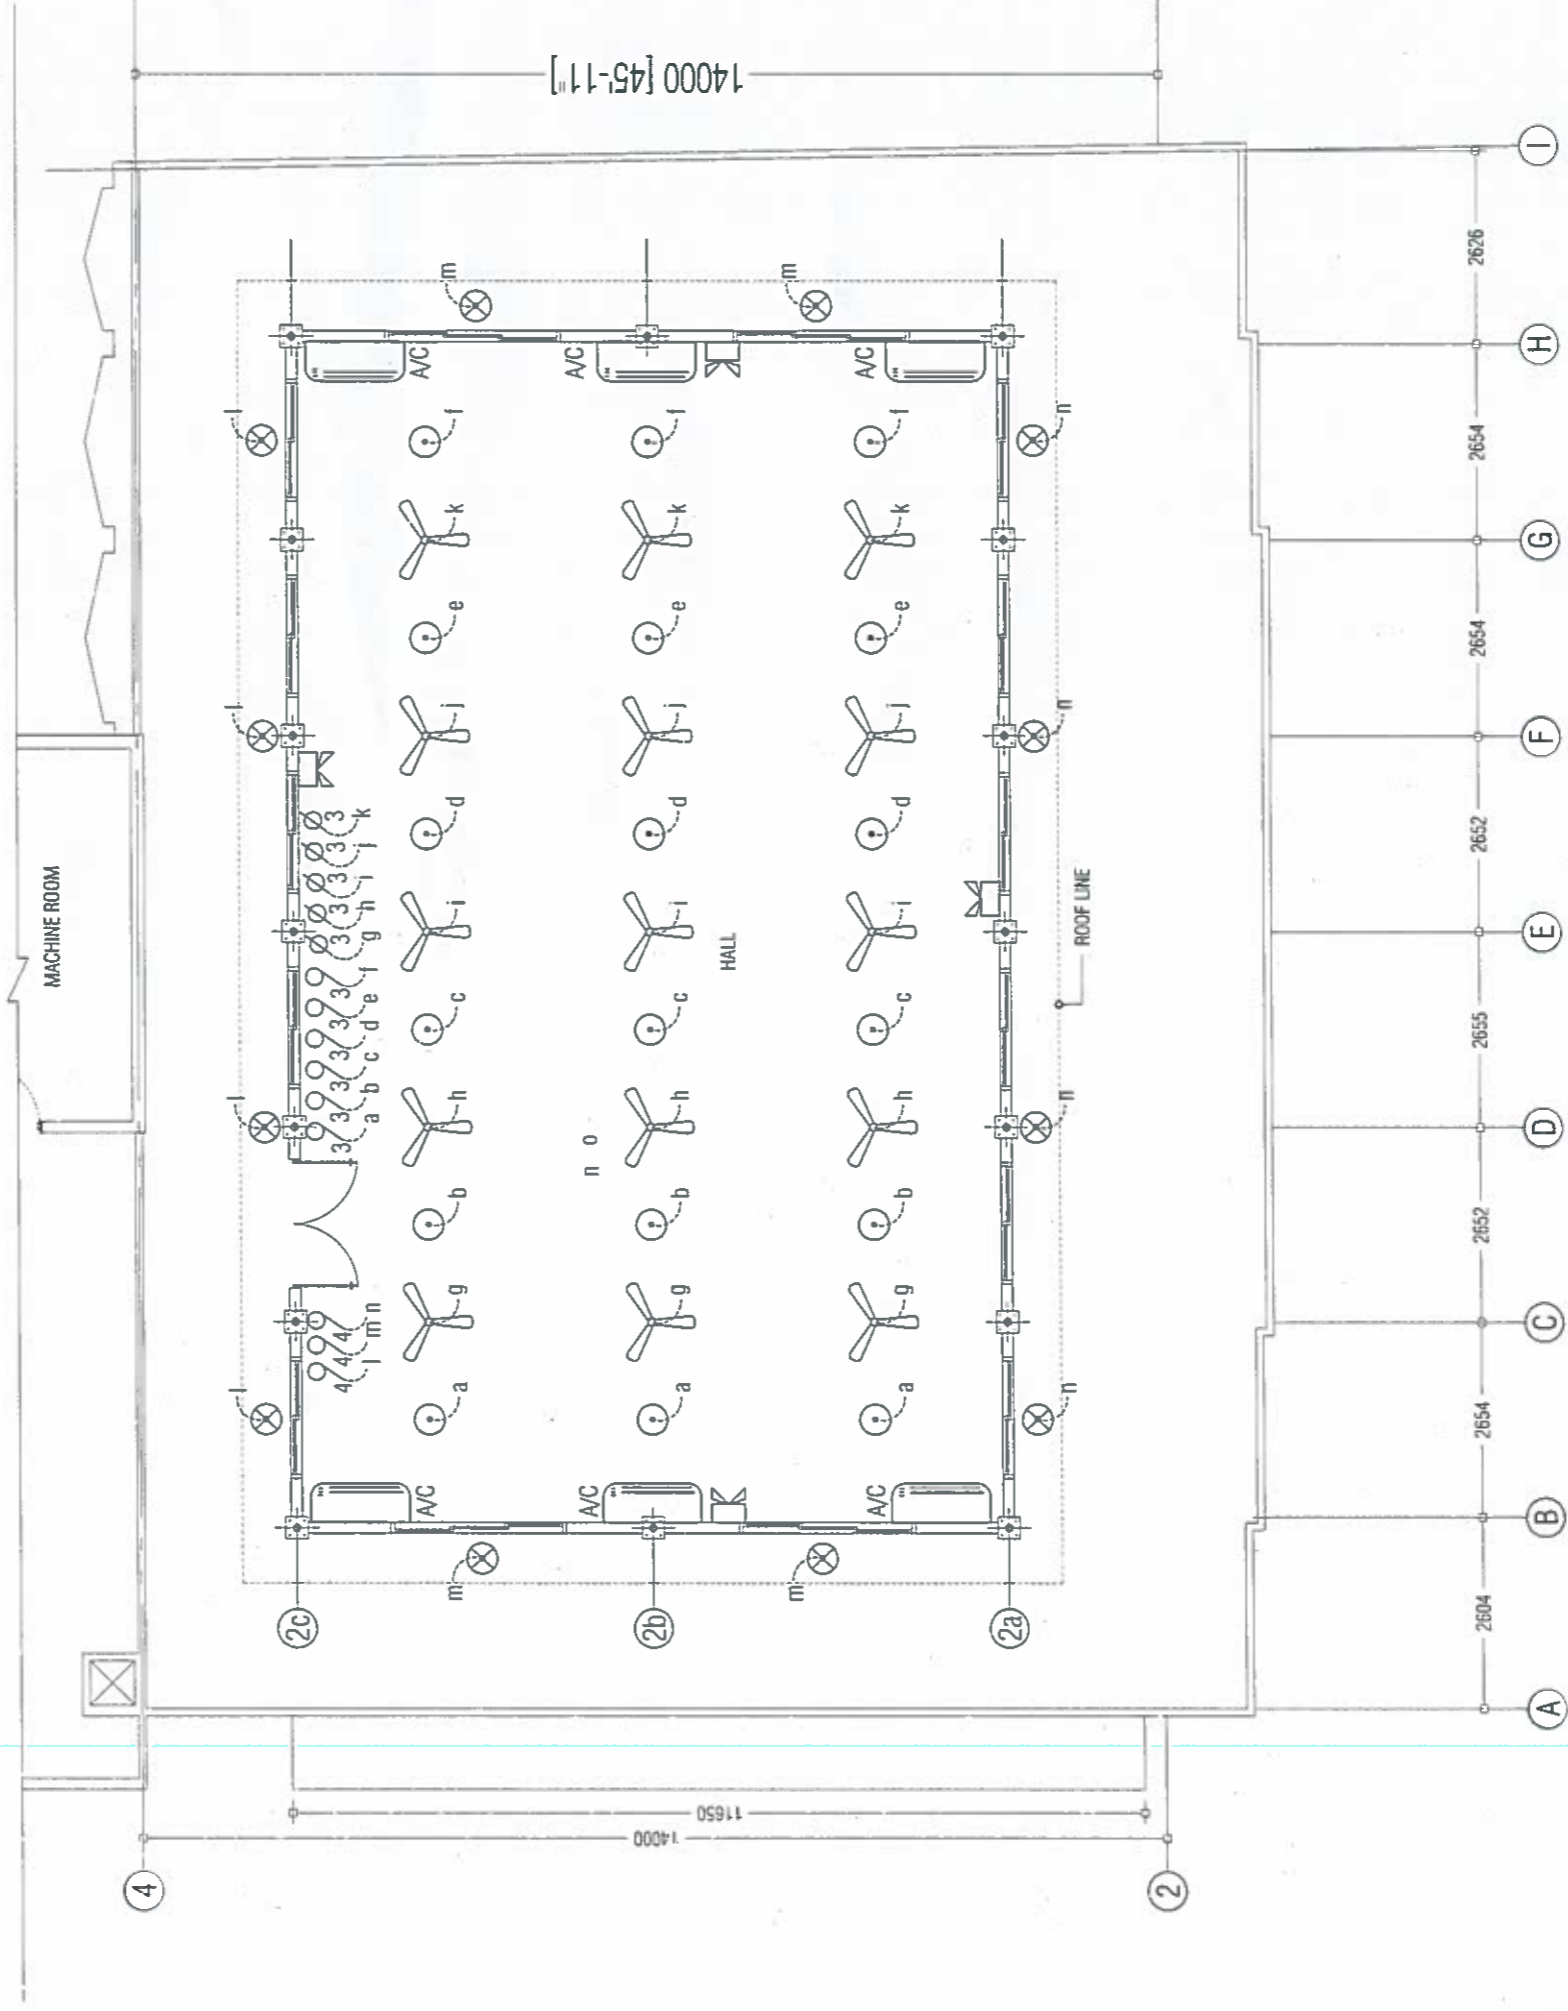

LIGHTING LAYOUT
 PROPOSED 7TH (TERRACE) FLOOR

Scale 1:100

Ministry of National Planning & Infrastructure
ACCREDITED CHECKER
 ARCHITECTURAL CHECKER B1
 Name: Ali Zameer
 Accredited No: BPR2019029B1
 VALIDITY: 24.02.19 - 23.02.20
 B1-2019-029-001

Ministry of National Planning & Infrastructure
ACCREDITED CHECKER
 STRUCTURAL CHECKER A1
 Name: Hussain Lizar
 Accredited No: BPR2019018A1
 VALIDITY: 28.01.19 - 27.01.20
 A1-2019-018-001

DWG NO:
 S01

PROJECT TITLE: INSTITUTE OF ISLAMIC STUDIES - 7TH FLOOR RECONSTRUCTION
 CLIENT: INSTITUTE OF ISLAMIC STUDIES
 SHEET CONTENTS: AS GIVEN


ARCHITECTURE: MOHAMMED YOUSUF
 ENGINEER: ALI AKRAM
 DRAWN BY: MOHAMMED SAMIR
 SCALE: 1:100
 DATE ISSUED: DEC-2019
 FILE: PROJECT OF ISLAMIC STUDIES.DWG
 REVISION NO.:

Rimaas pvt. ltd
 14, INDOLEENGA CALDWAY STREET
 FAREHIDE (INDIA)
 REP. OF MALAYSIA
 TEL: (084) 117 7783
 E-mail: info@rimaas.com

LEGEND:

SYMBOL	DESCRIPTION	SYMBOL	DESCRIPTION
	DISTRIBUTION BOARD		FAN DIMMER
	1x2 SOCKET OUTLET 13AMP		CEILING RECESSED LIGHTS DIA 150MM
	1x1 SOCKET OUTLET 15 AMP (FOR AIRCONDITION)		OUTDOOR CEILING MOUNT LIGHT
	1x1 SOCKET OUTLET 15 AMP (FOR EMERGENCY LIGHT)		EMERGENCY LIGHT (WALL MOUNT)
	TV POINT		1x3 SWITCH (3 GANG)
	NETWORK POINT		1x4 SWITCH (4 GANG)
	TELEPHONE POINT		A/C INDOOR WALL UNITS (24000 BTU)
	CEILING FAN		

NOTE:
 ALL WIRING TO BE OF STELCO APPROVED STANDARDS
 FLOOR LEVEL SOCKETS = 300MM FROM FLOOR FIN. LEVEL
 ALL SWITCHES AND FAN DIMMER = 1200MM FROM FLOOR FIN. LEVEL
 A/C / WH / EM / WP SOCKETS = 2500MM - 2700MM FROM FLOOR FIN. LEVEL

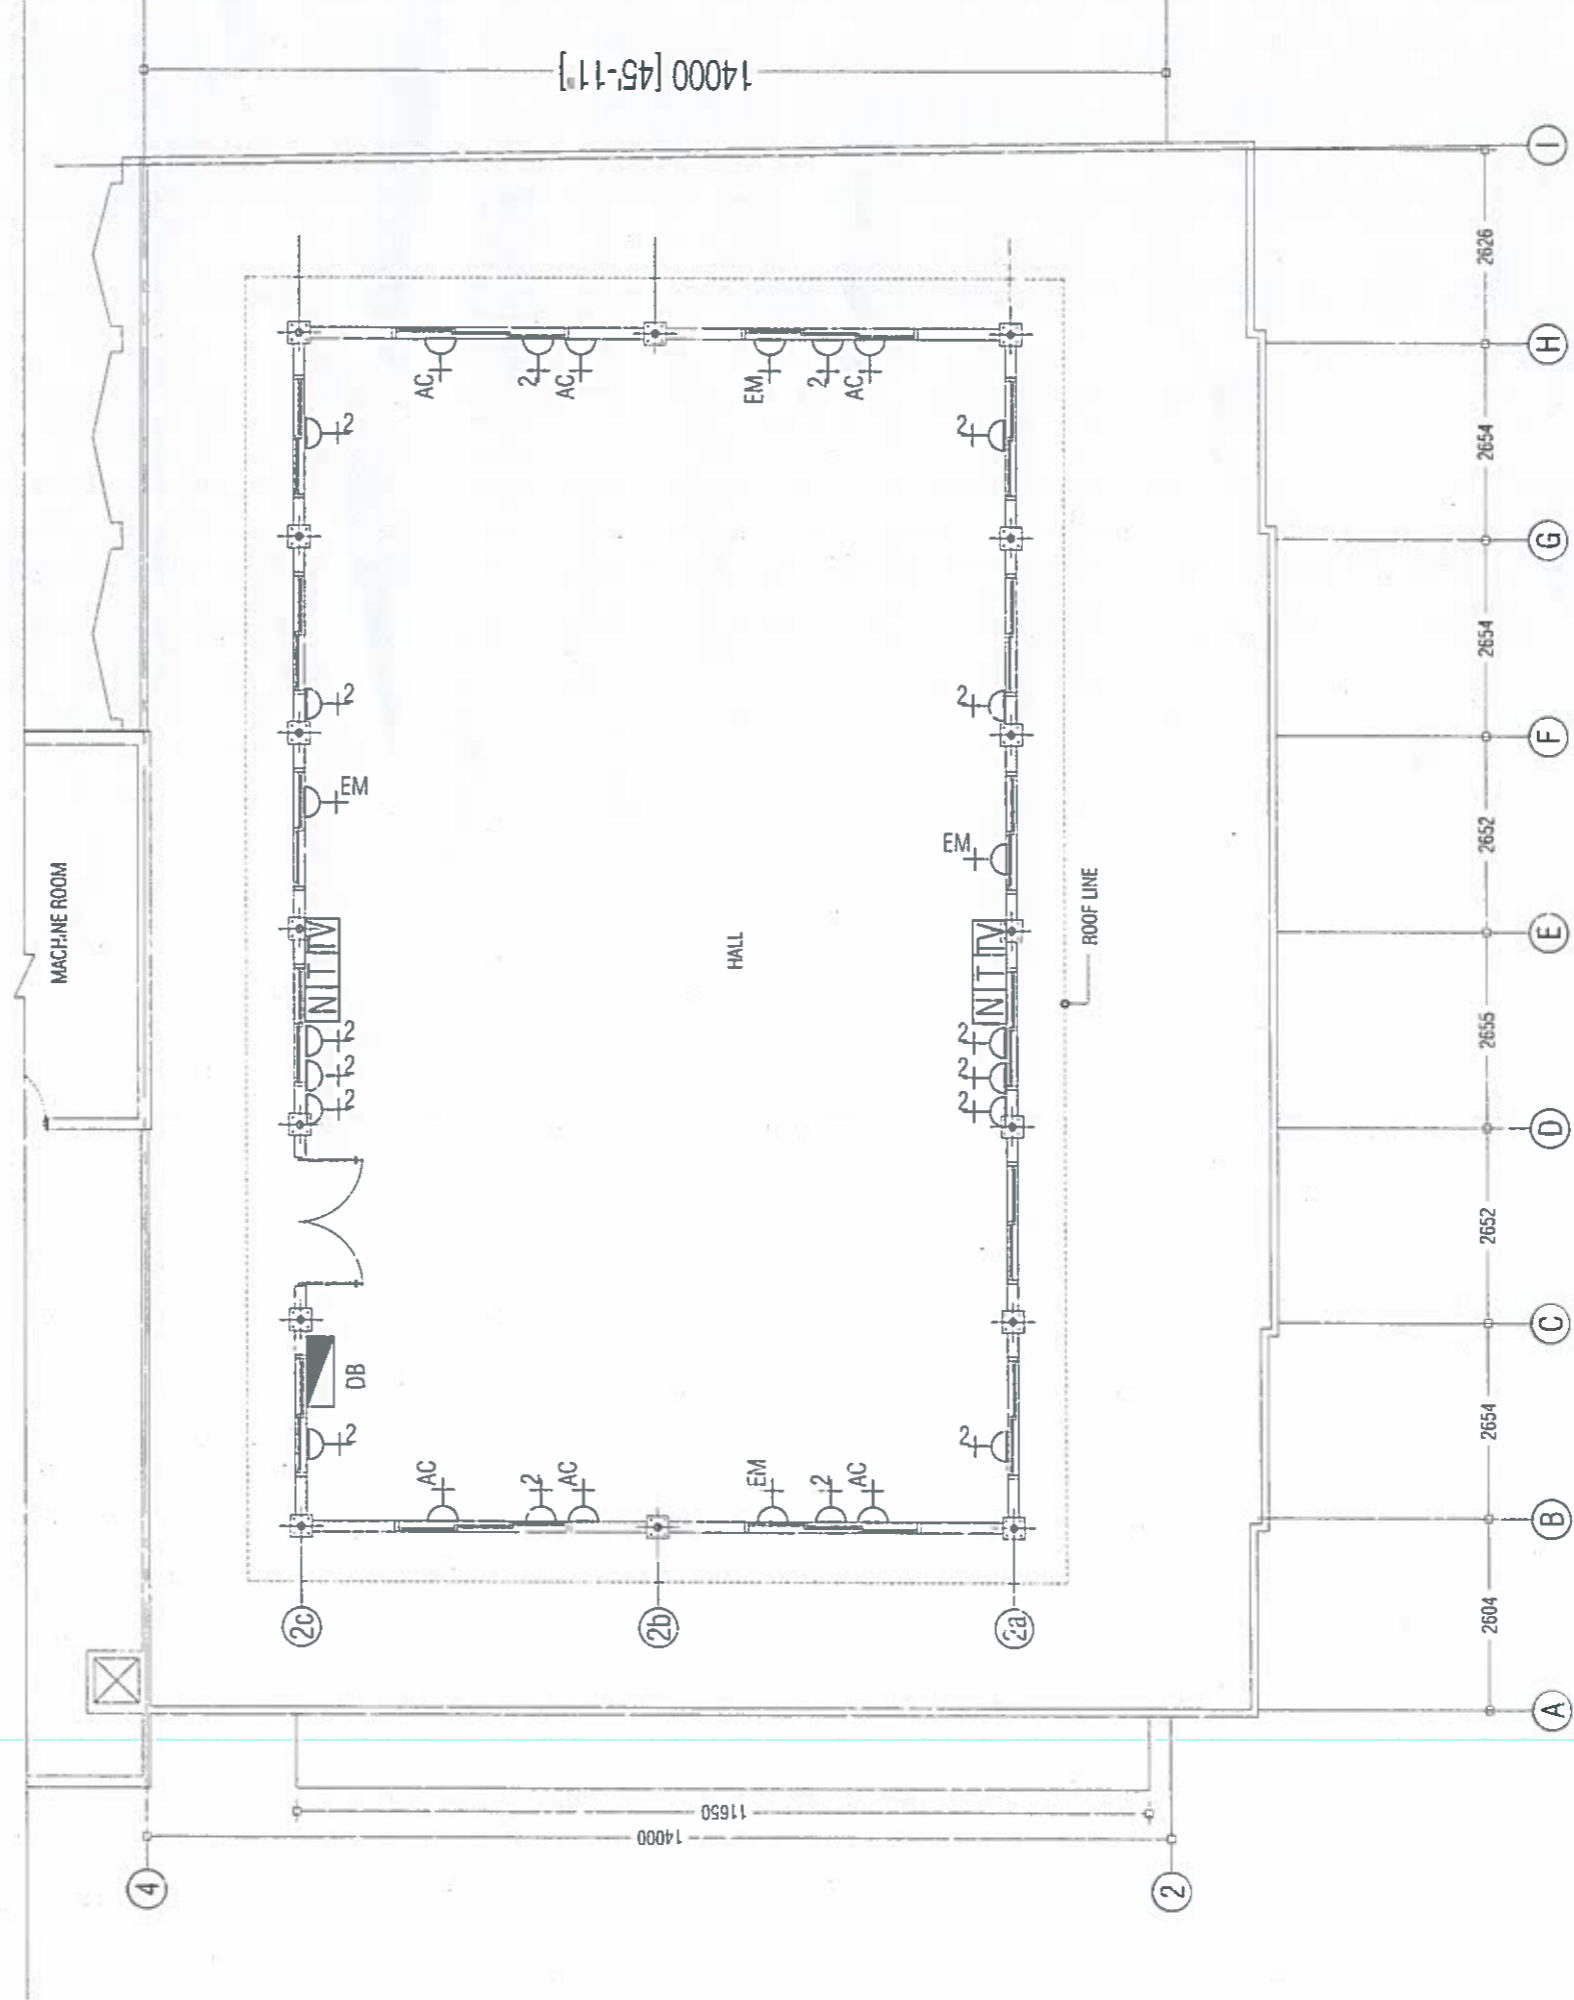

POWER LAYOUT
 PROPOSED 7TH (TERRACE) FLOOR
 Scale 1:100

Ministry of National Planning & Infrastructure
ACCREDITED CHECKER
 ARCHITECTURAL CHECKER B1
 Name: Ali Zameer VALIDITY: 24.02.19 - 23.02.20
 Accredited No: BPR201902981 B1-2019-029-001

Ministry of National Planning & Infrastructure
ACCREDITED CHECKER
 STRUCTURAL CHECKER A1
 Name: Hussain Lizar VALIDITY: 28.01.19 - 27.01.20
 Accredited No: BPR2019018A1 A1-2019-018-001

DWG NO:
 S02


PROJECT TITLE : INSTITUTE OF ISLAMIC STUDIES - 7TH FLOOR REFORMATION
 CLIENT : INSTITUTE OF ISLAMIC STUDIES
 SHEET CONTENTS : AS GIVEN

ARCHITECTURE: MOHAMED YOUSUF
 ENGINEER : ALI ARAHAM
 DRAWN BY : MOHAMED SAMIR
 SCALE: 1:100
 DATE ISSUED : DEC-2019
 FILE : PROJECT OF ISLAMIC STUDIES.DWG
 REVISION NO. :

Rimaas pvt. ltd
 14 BEDDING LANE, GOSWAMI BUILDING (LAD) REP. OF SAUDI ARABIA TEL: (966) 117 7881 E-mail: rimaas@rimgroup.com

LEGEND:

SYMBOL	DESCRIPTION	SYMBOL	DESCRIPTION
	CO2 2KG (ENCLOSED CABINET INCLUDE)		FIRE HORSE REEL
	9LTR. WATER		BELL
	(MCP) MANUAL CALL POINT		

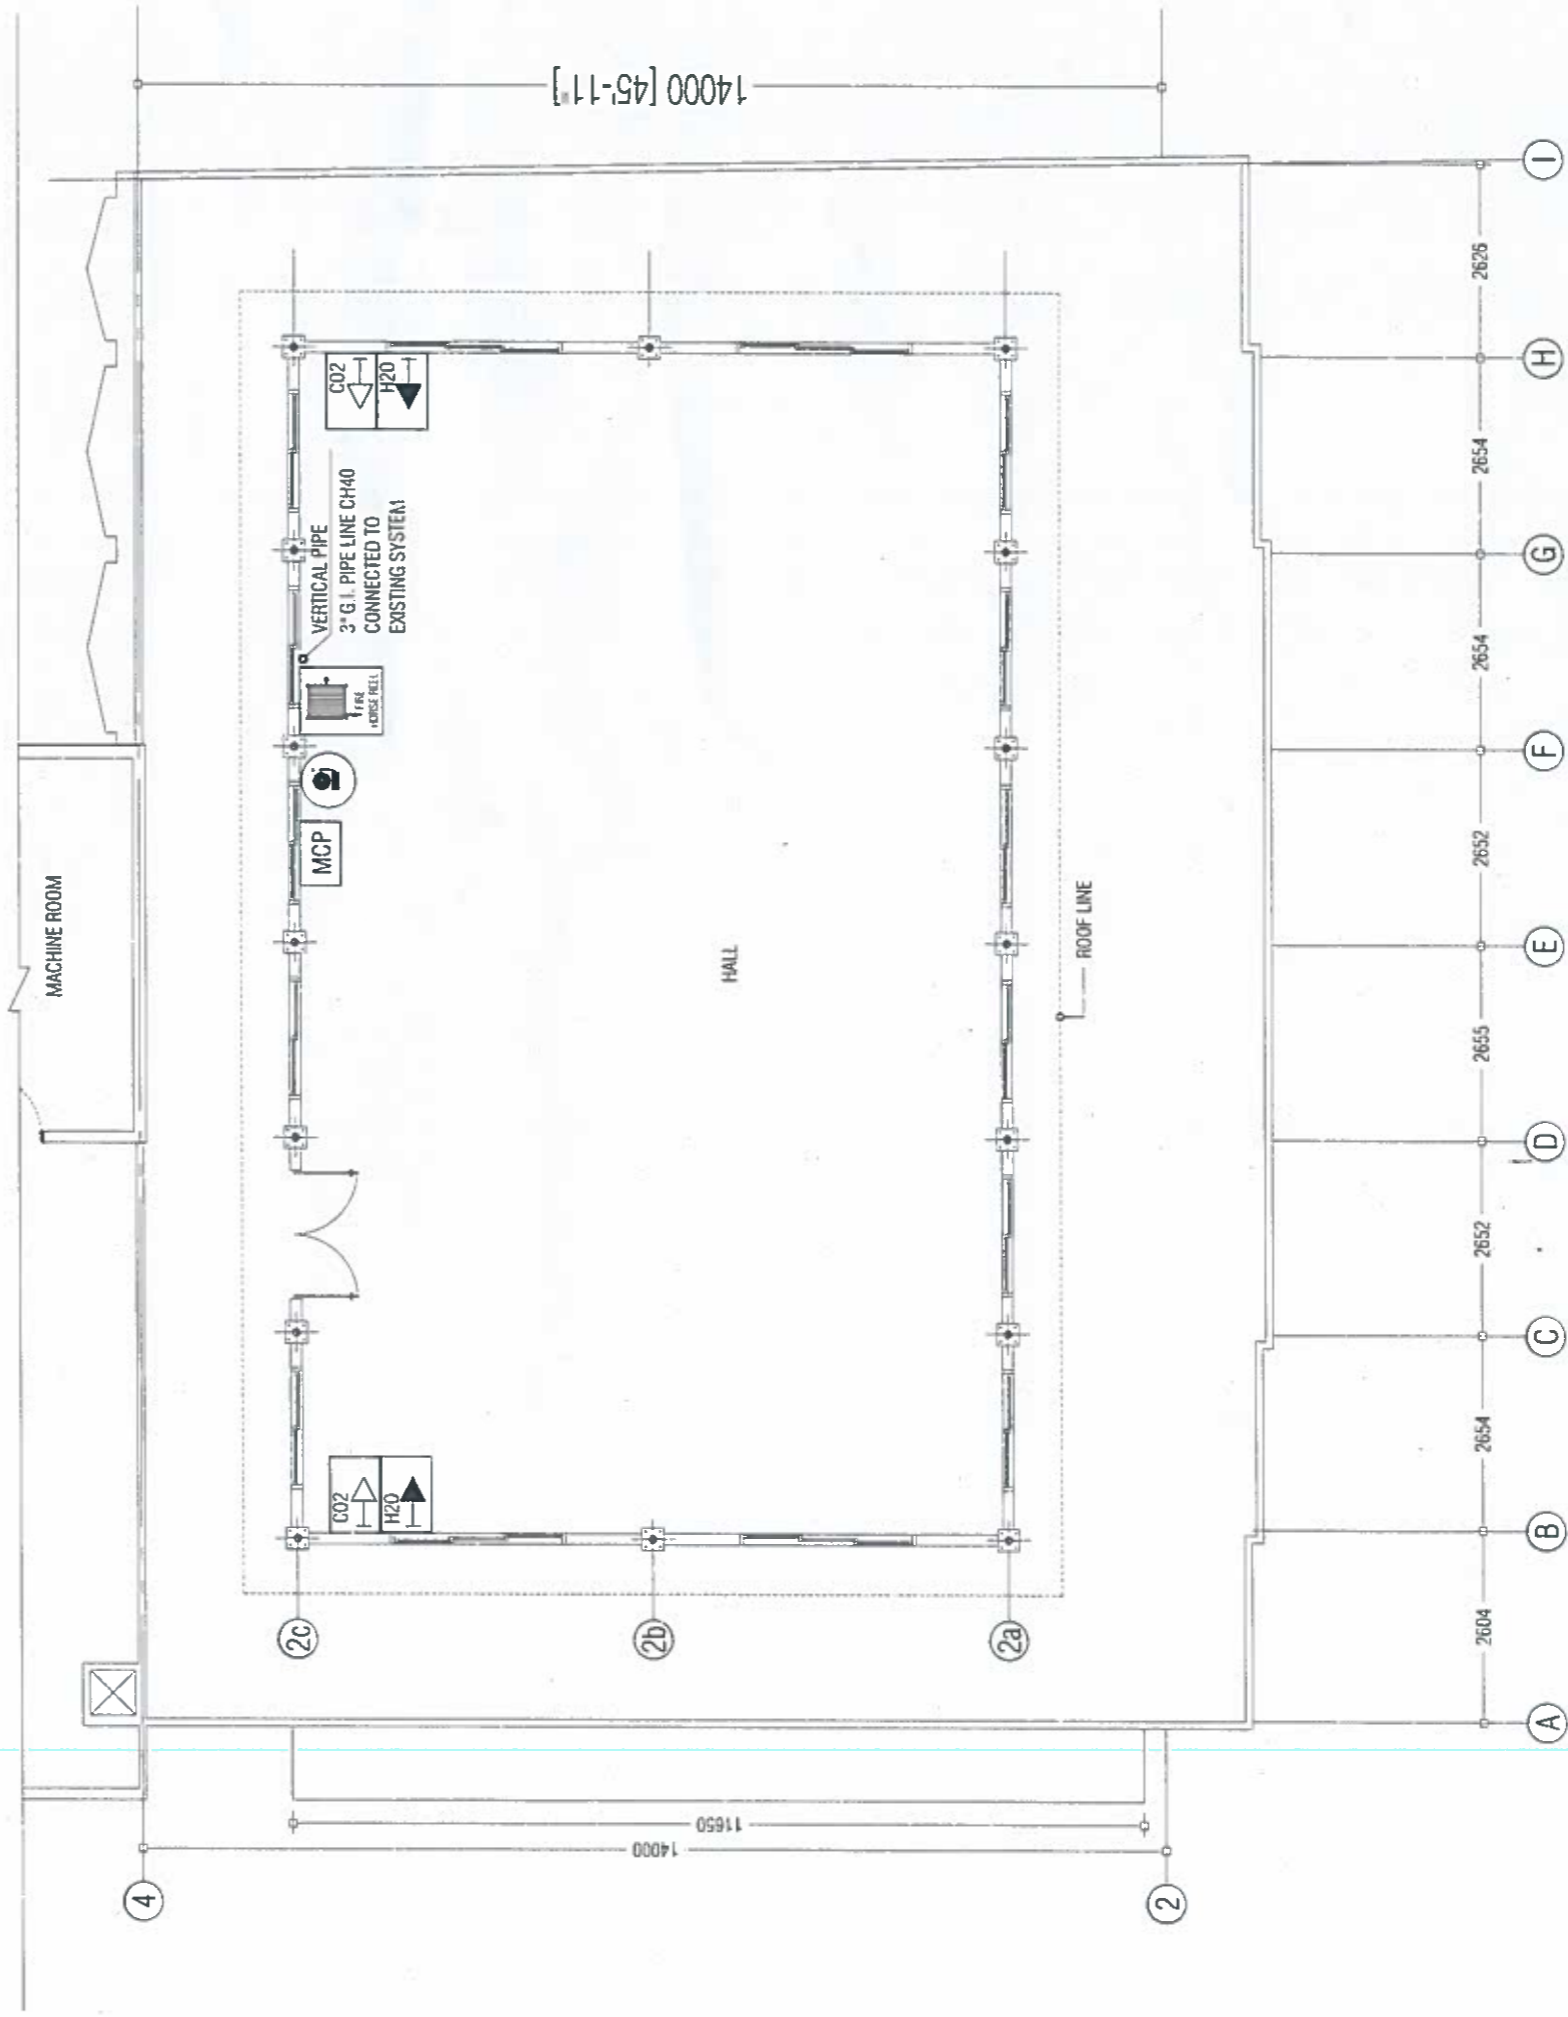

FIRE EXTINGUISHER LAYOUT
PROPOSED 7TH (TERRACE) FLOOR

Scale 1:100

Ministry of National Planning & Infrastructure
ACCREDITED CHECKER
ARCHITECTURAL CHECKER B1
Name: Ali Zameer
Accredited No: BPR2019029B1
VALIDITY: 24.02.19-23.02.20
01-2019-029-001

Ministry of National Planning & Infrastructure
ACCREDITED CHECKER
STRUCTURAL CHECKER A1
Name: Hussain Lizar
Accredited No: BPR2019018A1
VALIDITY: 28.01.19-27.01.20
A1-2019-018-001

DWG NO:
S03

PROJECT TITLE : INSTITUTE OF ISLAMIC STUDIES
ZEELEKH ABRIYATULYAH
CLIENT : INSTITUTE OF ISLAMIC STUDIES
SHEET CONTENTS : AS GIVEN

ARCHITECTURE: MOHAMMED YOUSUF
ENGINEER : ALI ANJAM
DRAWN BY : MOHAMMED SAMIR
SCALE: 1:100
DATE ISSUED : DEL-2019
FILE : PROJECT OF ISLAMIC STUDIES.PDW
REVISION NO. :

Rimaas
Pvt. Ltd
M. SOOJAN, CHAIRMAN
M. YOUSUF, CEO
M. ALI ANJAM, CTO
M. ALI ZAMEER, CFO
M. ALI ANJAM, HR
M. ALI ANJAM, IT
M. ALI ANJAM, LEGAL
M. ALI ANJAM, SECURITY
M. ALI ANJAM, TRAINING
M. ALI ANJAM, WELFARE
M. ALI ANJAM, WORKSHOP
M. ALI ANJAM, ZONE