


F.Maaenboodhoo Health Center Portico

Scale 1:100

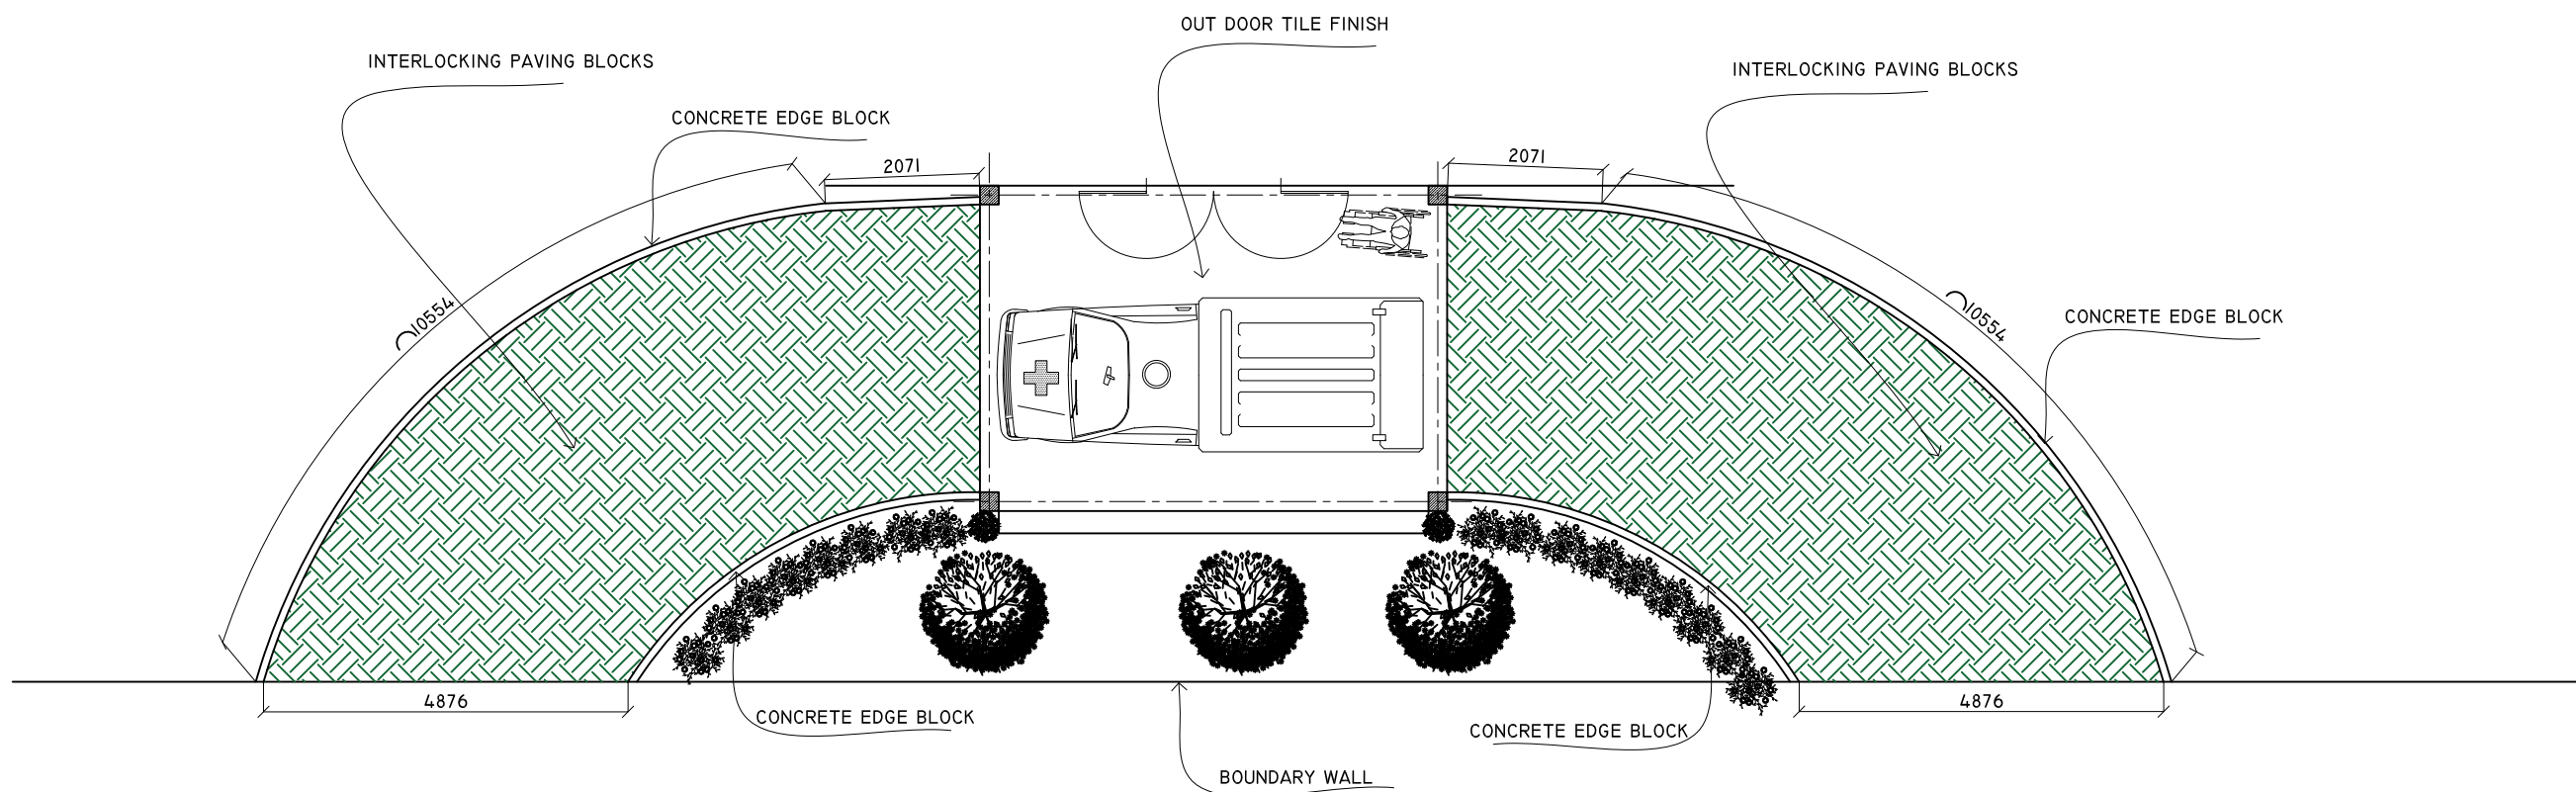

SHEET CONTENTS :

REVISION NOTES:

PROJECT:

CONSTRUCTION OF
AMBULANCE PORTICO

CLIENT:

MINISTRY OF HEALTH

LOCATION:

DIFFERENT ISLANDS

CONTENTS: AS GIVEN

PROJECT MANAGER:

DESIGNER: ARIZ

CIV/STR. ENGINEER:

SURVEYED BY: -

DRAWN BY: ARIZ

CHECKED BY:

DATE : FEBRUARY 2021

SHEET NO. : /


PAPER SIZE: A3



ADMIN DIVISION
Ministry of Health
Roshanee Building
Sosun Magu
Tel: 332 8887, Fax: 3328889


COLUMN AND FOOTING PLAN

SCALE: 1 : 100

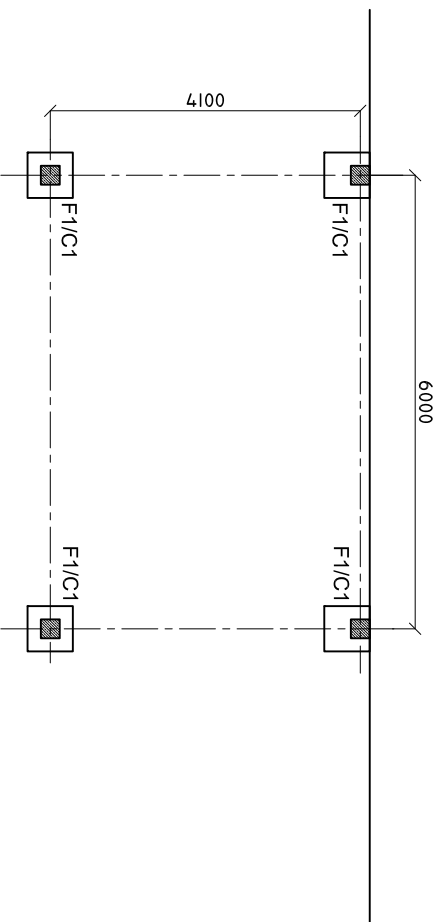


TIE BEAM PLAN

SCALE: 1 : 100

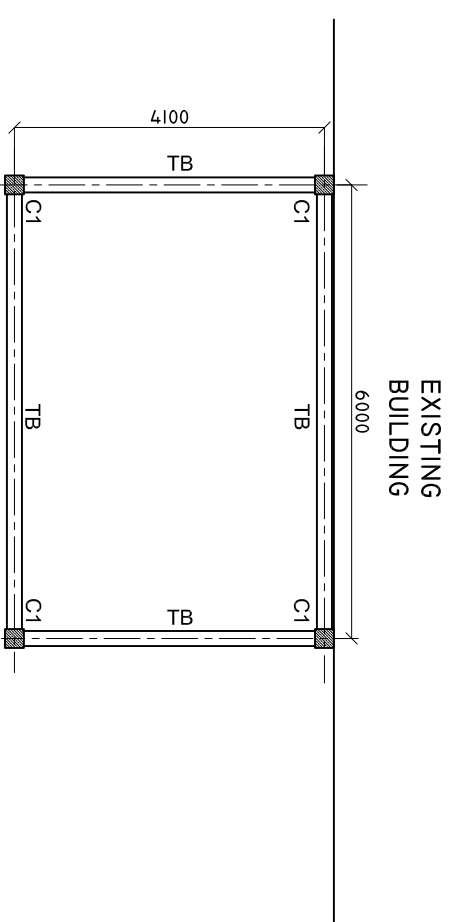


ROOF BEAM PLAN

SCALE: 1 : 100

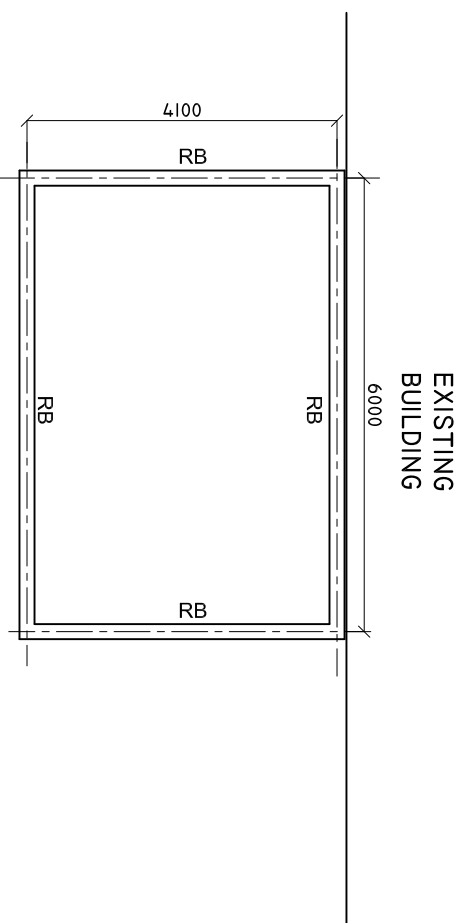

DETAILS R/C

SCALE: 1 : 25

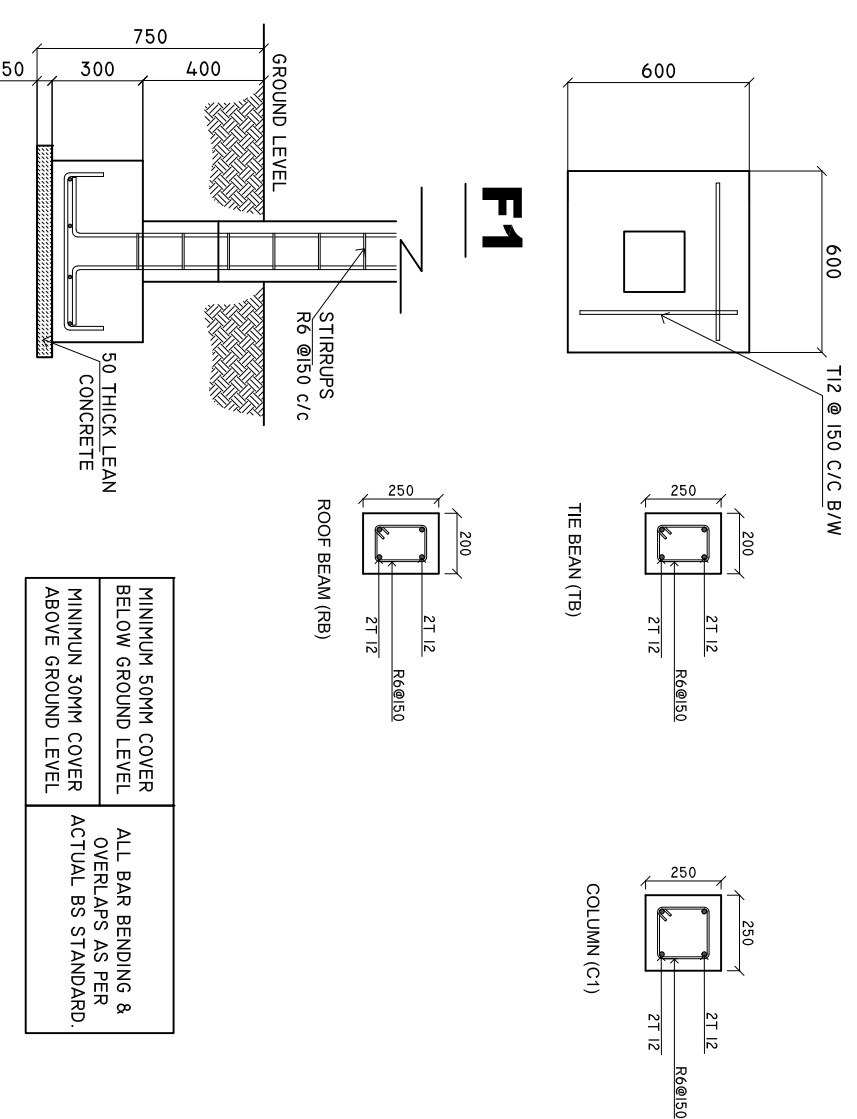

SHEET CONTENTS :

REVISION NOTES:

PROJECT: CONSTRUCTION OF AMBULANCE PORTICO

CLIENT: MINISTRY OF HEALTH

LOCATION: DIFFERENT ISLANDS

CONTENTS: AS GIVEN

PROJECT MANAGER:

DESIGNER: ARIZ

CIV/STR. ENGINEER:

SURVEYED BY: -

DRAWN BY: ARIZ

CHECKED BY:

DATE : FEBRUARY 2021

SHEET NO. : /


PAPER SIZE: A3



ADMIN DIVISION
Ministry of Health
Rosharae Building
Soosan Majeed
Tel: 332 8887, Fax: 332 8889


FRONT ELEVATION

SCALE: 1:50

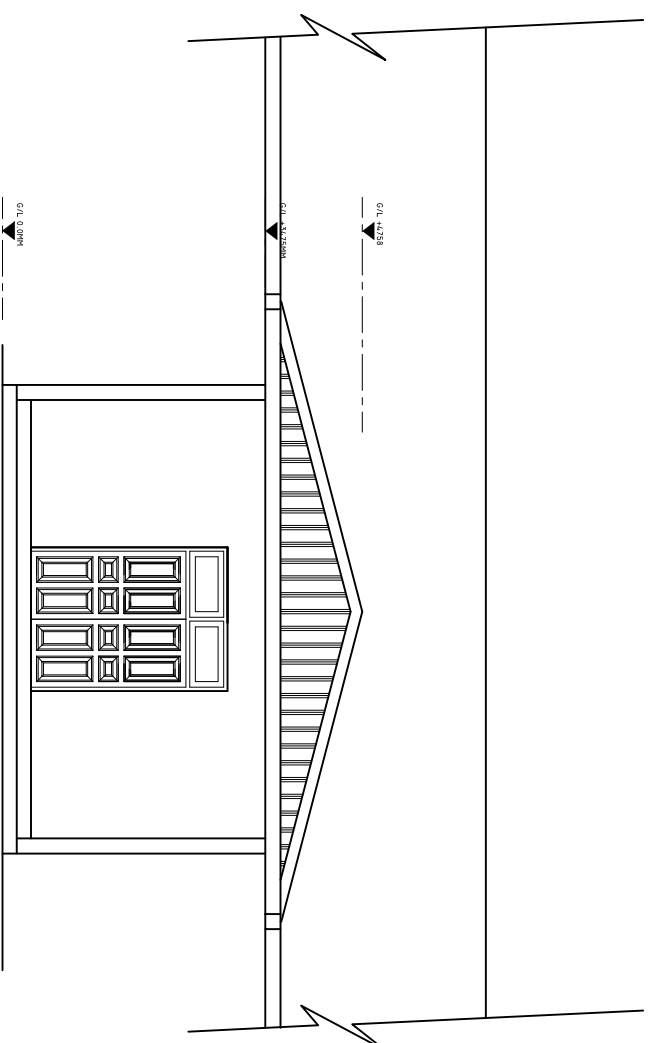

SIDE ELEVATION


SCALE: 1:50

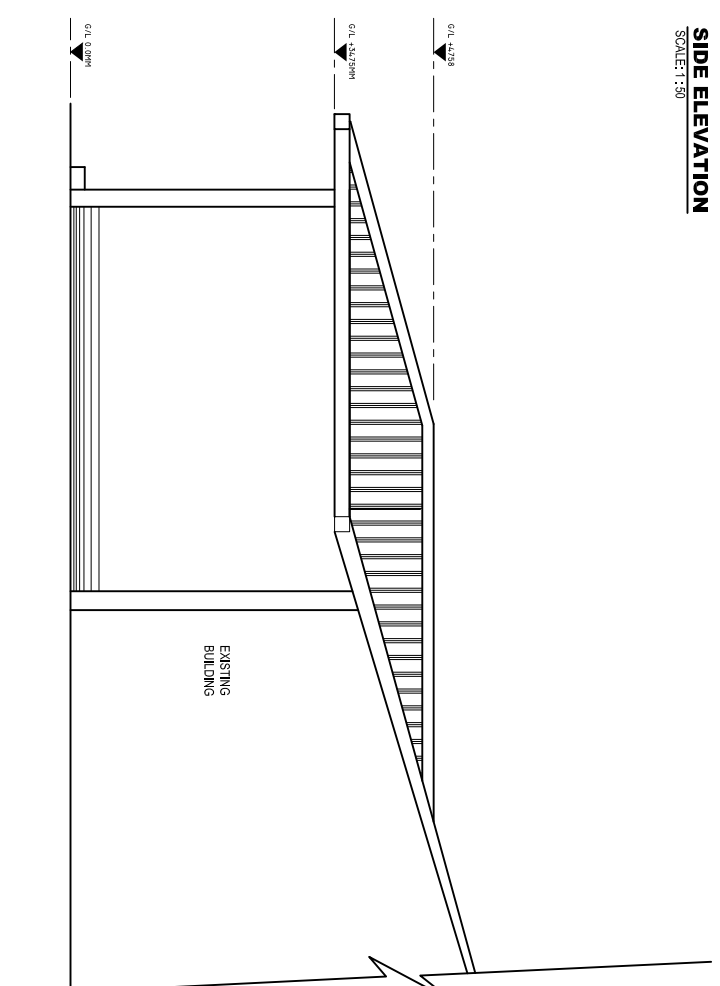

ELECTRICAL LAYOUT

SCALE: 1 : 100

EXISTING BUILDING

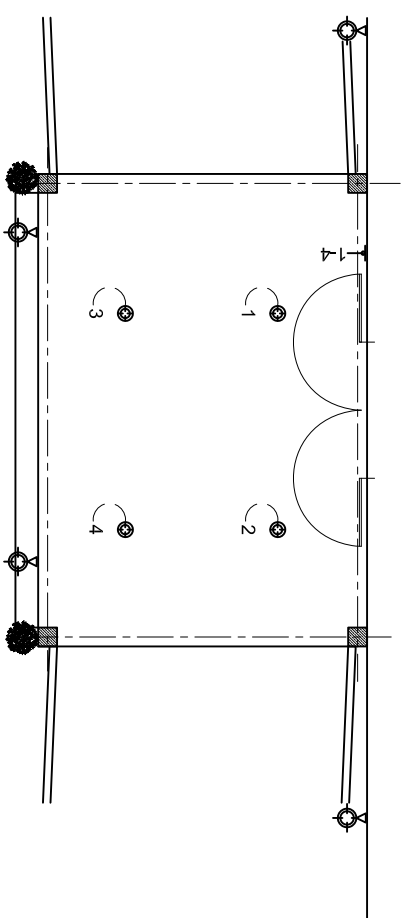

LEGEND

SYMBOL	DESCRIPTION
	OUR DOOR WHETHER PROOF LIGHT 21W PHILIPS.
	FOUR GANG SWITCH
	OUTDOOR WHETHER PROOF LIGHT 21W PHILIPS.

SHEET CONTENTS :

REVISION NOTES:

PROJECT:
CONSTRUCTION OF
AMBULANCE PORTICO

CLIENT:

MINISTRY OF HEALTH

LOCATION:
DIFFERENT ISLANDS

CONTENTS: AS GIVEN

PROJECT MANAGER:

DESIGNER: ARIZ

CIV/STR. ENGINEER:

SURVEYED BY: -

DRAWN BY: ARIZ

CHECKED BY:

DATE : FEBRUARY 2021

SHEET NO. : /



PAPER SIZE: A3



ADMIN DIVISION
Ministry of Health
Residence Building
Suva, Malaga
Tel: 332 8887, Fax: 332 8889

ROOF PLAN

SCALE: 1 : 100

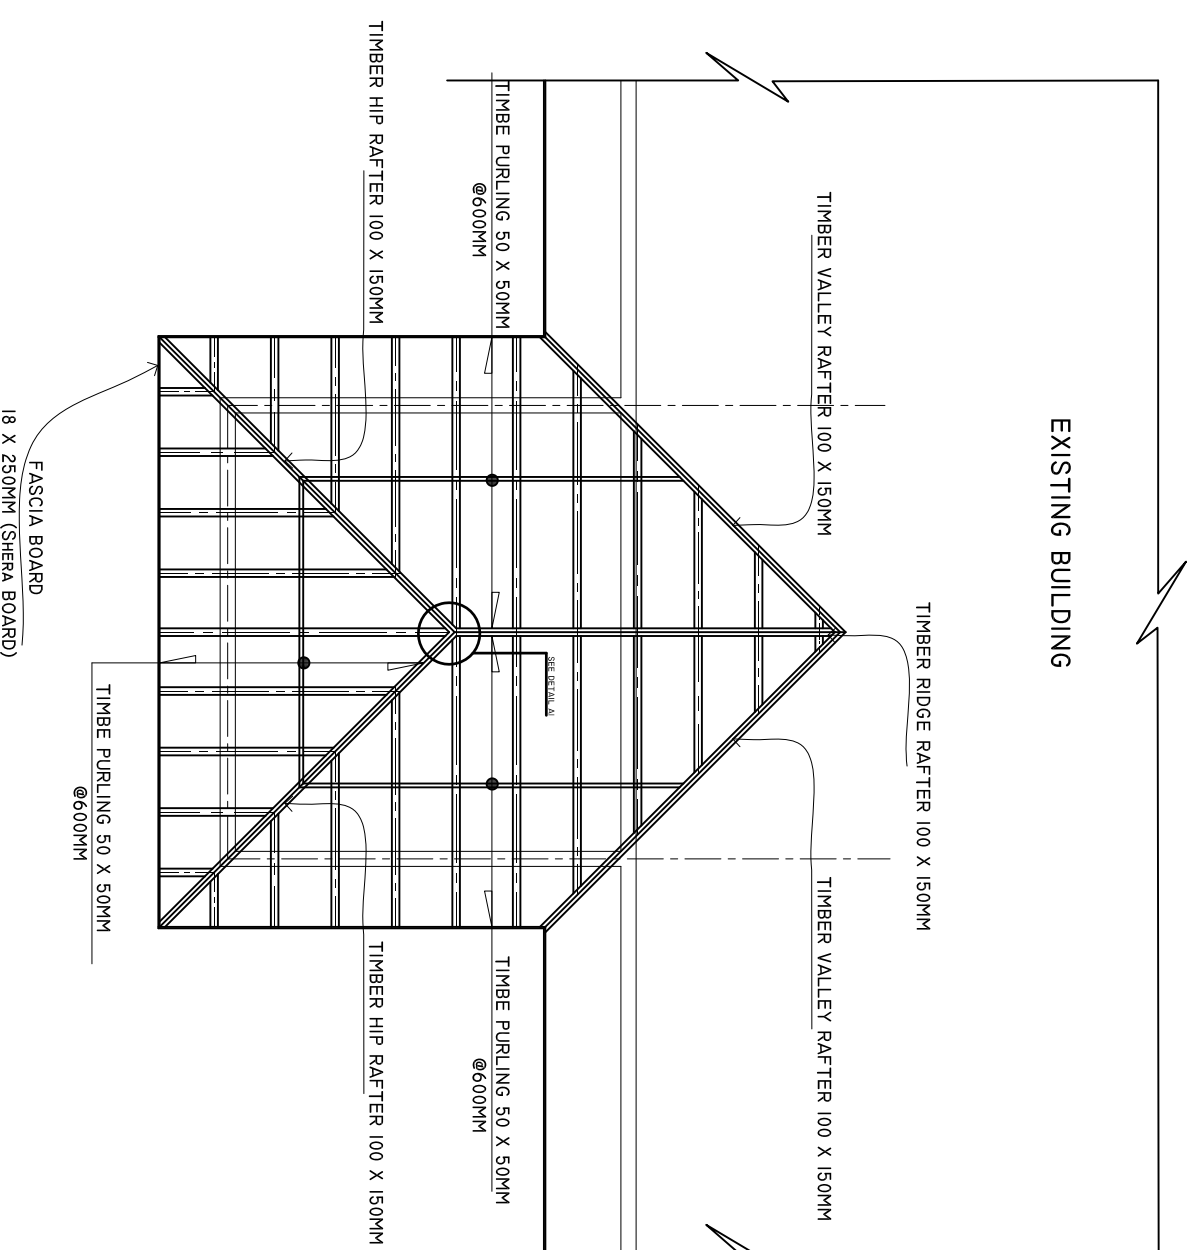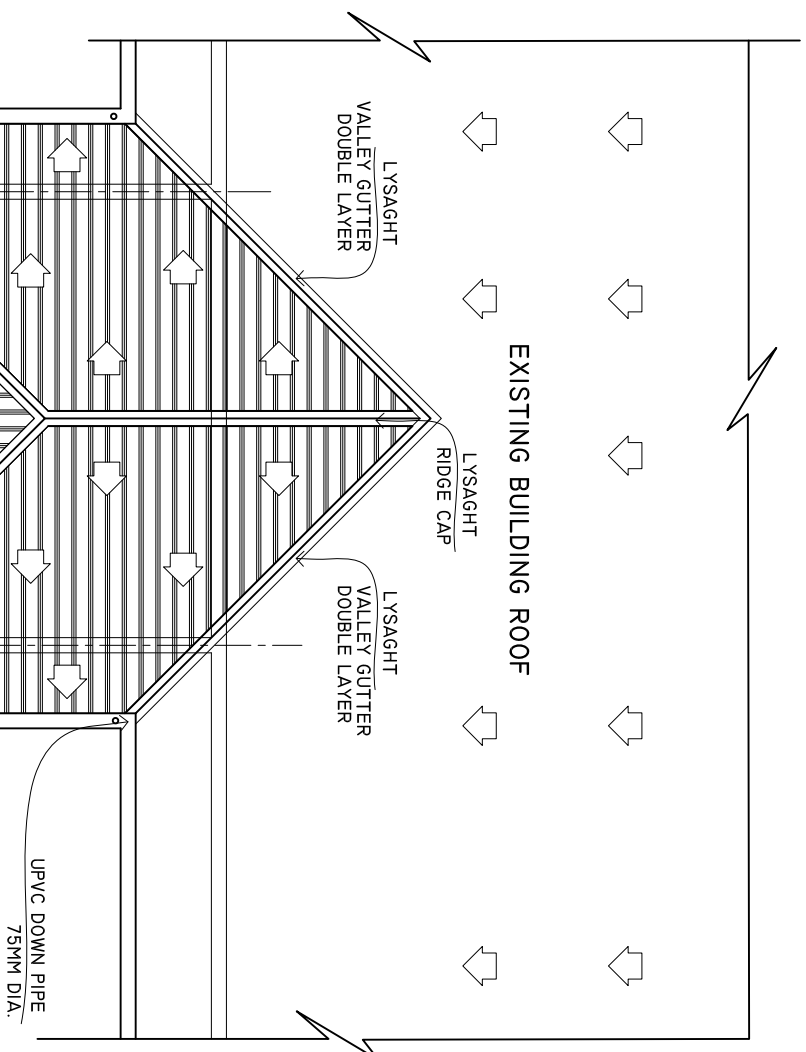

SHEET CONTENTS :

REVISION NOTES:

PROJECT:
CONSTRUCTION OF
AMBULANCE PORTICO

CLIENT:
MINISTRY OF HEALTH

LOCATION:
DIFFERENT ISLANDS

CONTENTS: AS GIVEN

PROJECT MANAGER:

DESIGNER: ARIZ

CIV/STR. ENGINEER:

SURVEYED BY: -

DRAWN BY: ARIZ

CHECKED BY:

DATE : FEBRUARY 2021

SHEET NO. : /


PAPER SIZE: A3



ADMIN DIVISION
Ministry of Health
Roshanah Building
Soan Mazar
Tel: 332 8887, Fax: 332 8889

CROSS SECTION X-X

SCALE: 1 : 50

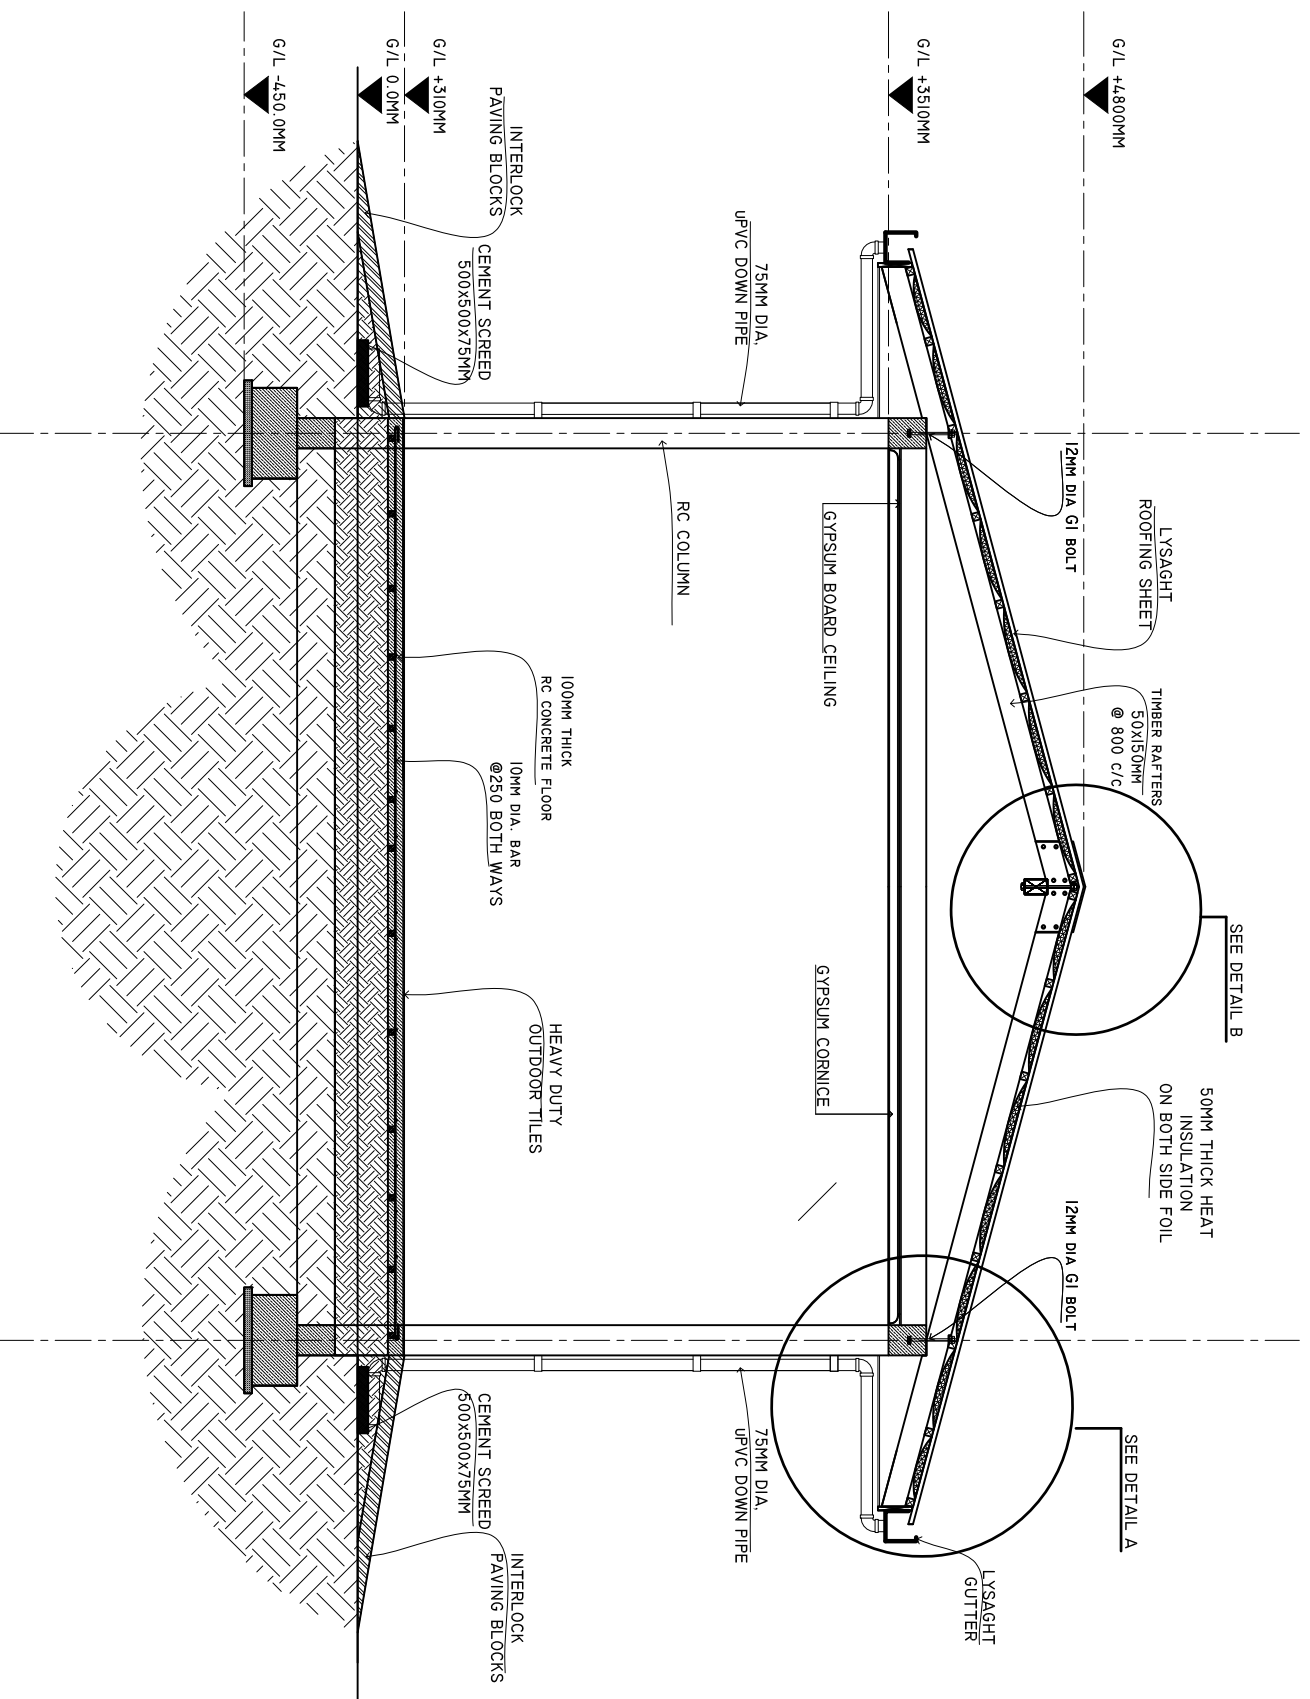

SHEET CONTENTS :

REVISION NOTES:

PROJECT:

CONSTRUCTION OF
AMBULANCE PORTICO

CLIENT:

MINISTRY OF HEALTH

LOCATION:
DIFFERENT ISLANDS

CONTENTS: AS GIVEN

PROJECT MANAGER:

DESIGNER: ARIZ

CIV/STR. ENGINEER:

SURVEYED BY: -

DRAWN BY: ARIZ

CHECKED BY:

DATE : FEBRUARY 2021


SHEET NO. : /

PAPER SIZE: A3



DETAIL A

SCALE: 1 : 10

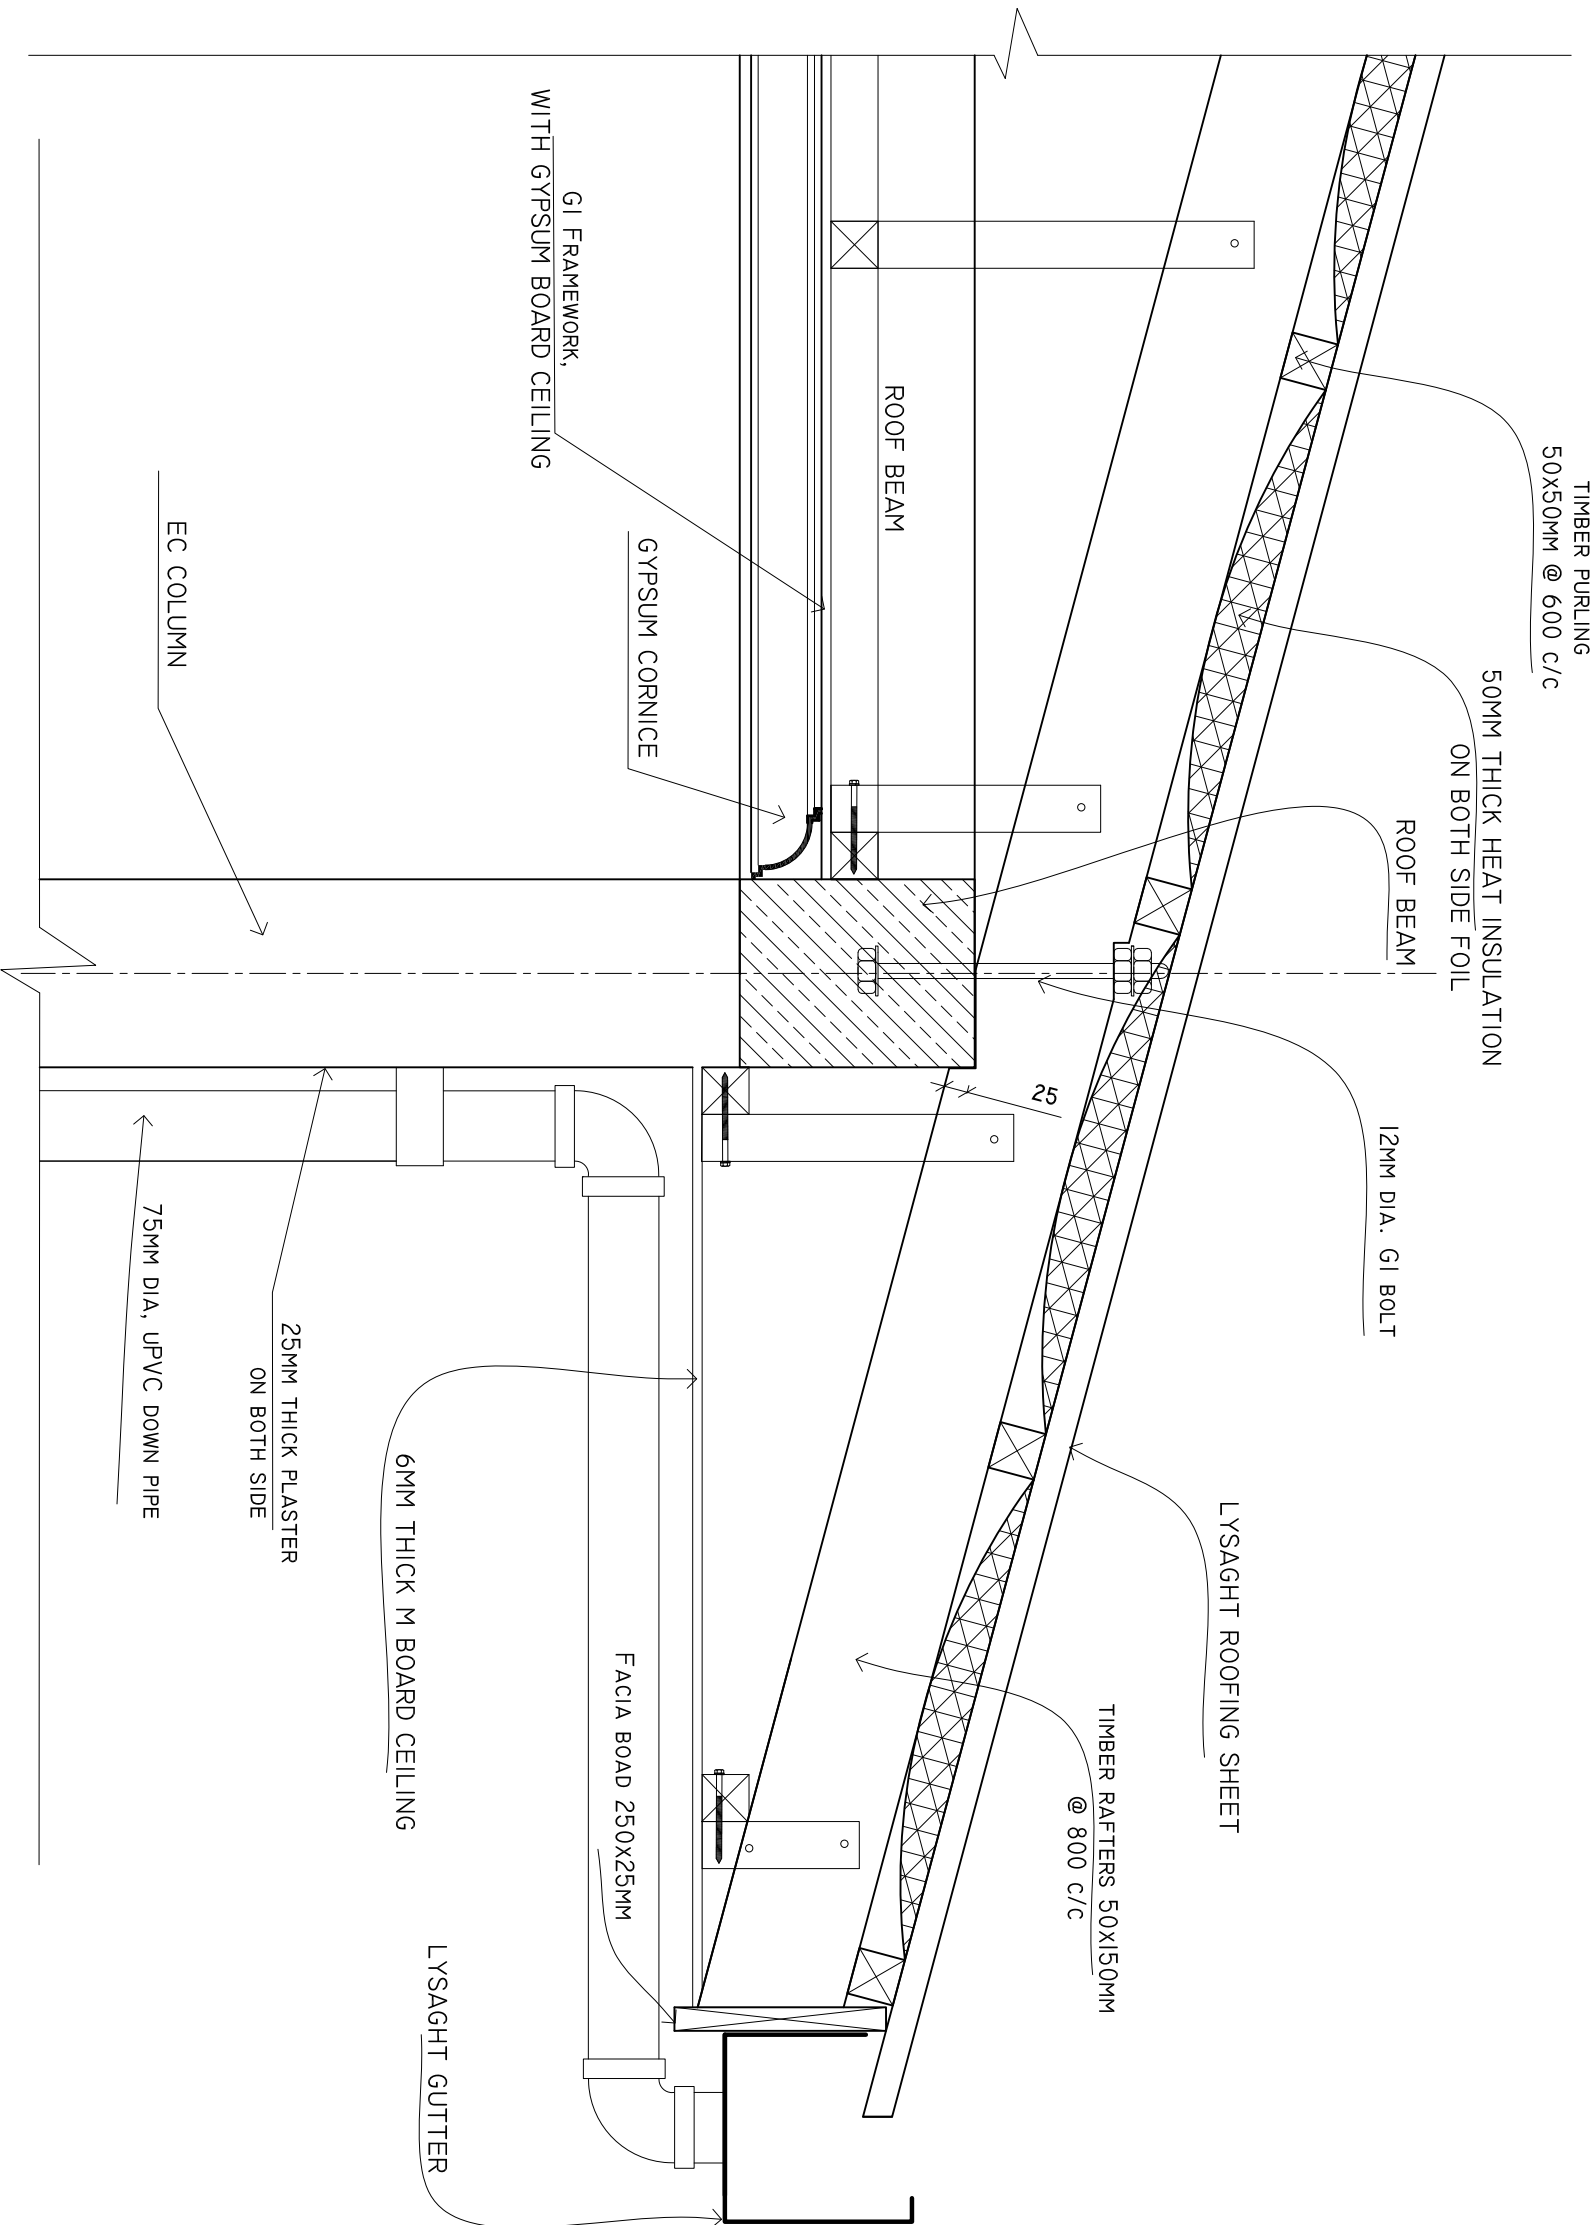

SHEET CONTENTS :

REVISION NOTES:

PROJECT:
CONSTRUCTION OF
AMBULANCE PORTICO

CLIENT:
MINISTRY OF HEALTH

LOCATION:
DIFFERENT ISLANDS

CONTENTS: AS GIVEN

PROJECT MANAGER:

DESIGNER: ARIZ

CIV/STR. ENGINEER:

SURVEYED BY: -

DRAWN BY: ARIZ

CHECKED BY:

DATE : FEBRUARY 2021


SHEET NO. : /

PAPER SIZE: A3



ADMIN DIVISION
Ministry of Health
Roshanah Building
Soana Maaga
Tel: 332 8887, Fax: 332 8889

DETAIL B
SCALE: 1 : 10

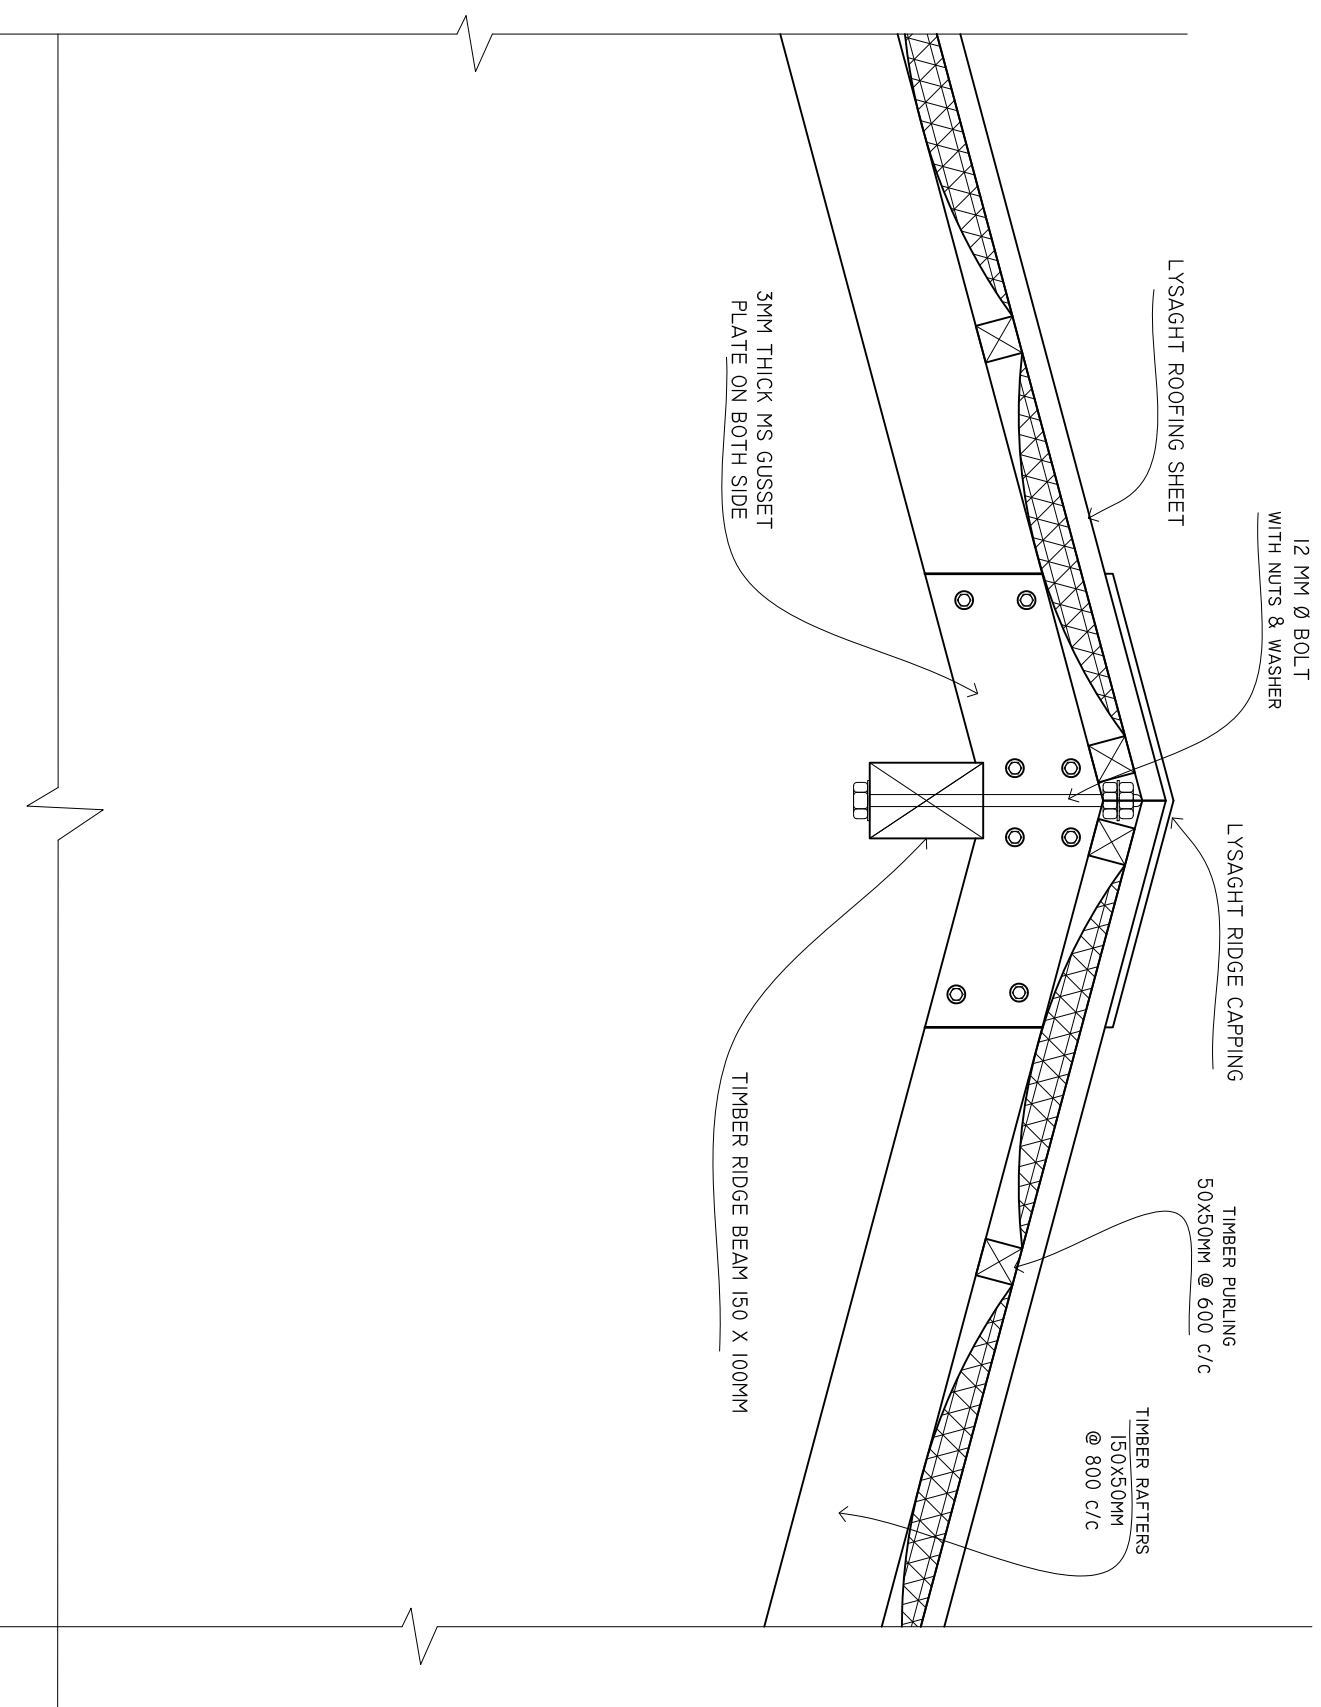

SHEET CONTENTS :

REVISION NOTES:

PROJECT:
CONSTRUCTION OF
AMBULANCE PORTICO

CLIENT:
MINISTRY OF HEALTH

LOCATION:
DIFFERENT ISLANDS

CONTENTS: AS GIVEN

PROJECT MANAGER:

DESIGNER: ARIZ

CIV/STR. ENGINEER:

SURVEYED BY: -

DRAWN BY: ARIZ

CHECKED BY:

DATE : FEBRUARY 2021

SHEET NO. : /


PAPER SIZE: A3



ADMIN DIVISION
Ministry of Health
Roshanee Building
Soana Maaga
Tel: 332 8887, Fax: 3328889

DETAILS A1

SCALE: 1 : 10

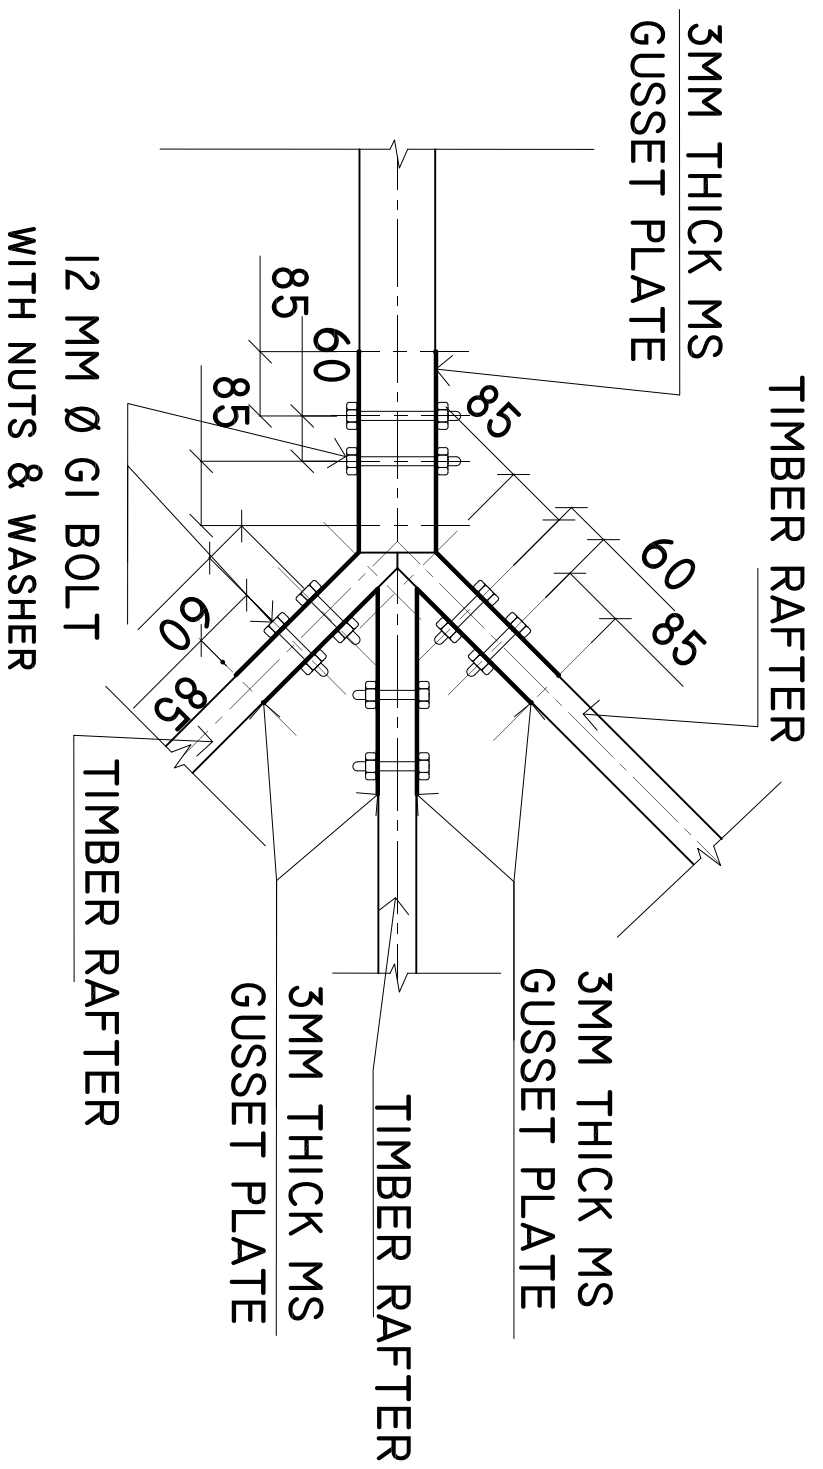

SHEET CONTENTS :

REVISION NOTES:

PROJECT:
CONSTRUCTION OF
AMBULANCE PORTICO

CLIENT:
MINISTRY OF HEALTH

LOCATION:
DIFFERENT ISLANDS

CONTENTS: AS GIVEN

PROJECT MANAGER:

DESIGNER: ARIZ

CIV/STR. ENGINEER:

SURVEYED BY: -

DRAWN BY: ARIZ

CHECKED BY:

DATE : FEBRUARY 2021


SHEET NO. : /

PAPER SIZE: A3




DETAILS A1

SCALE: 1 : 10

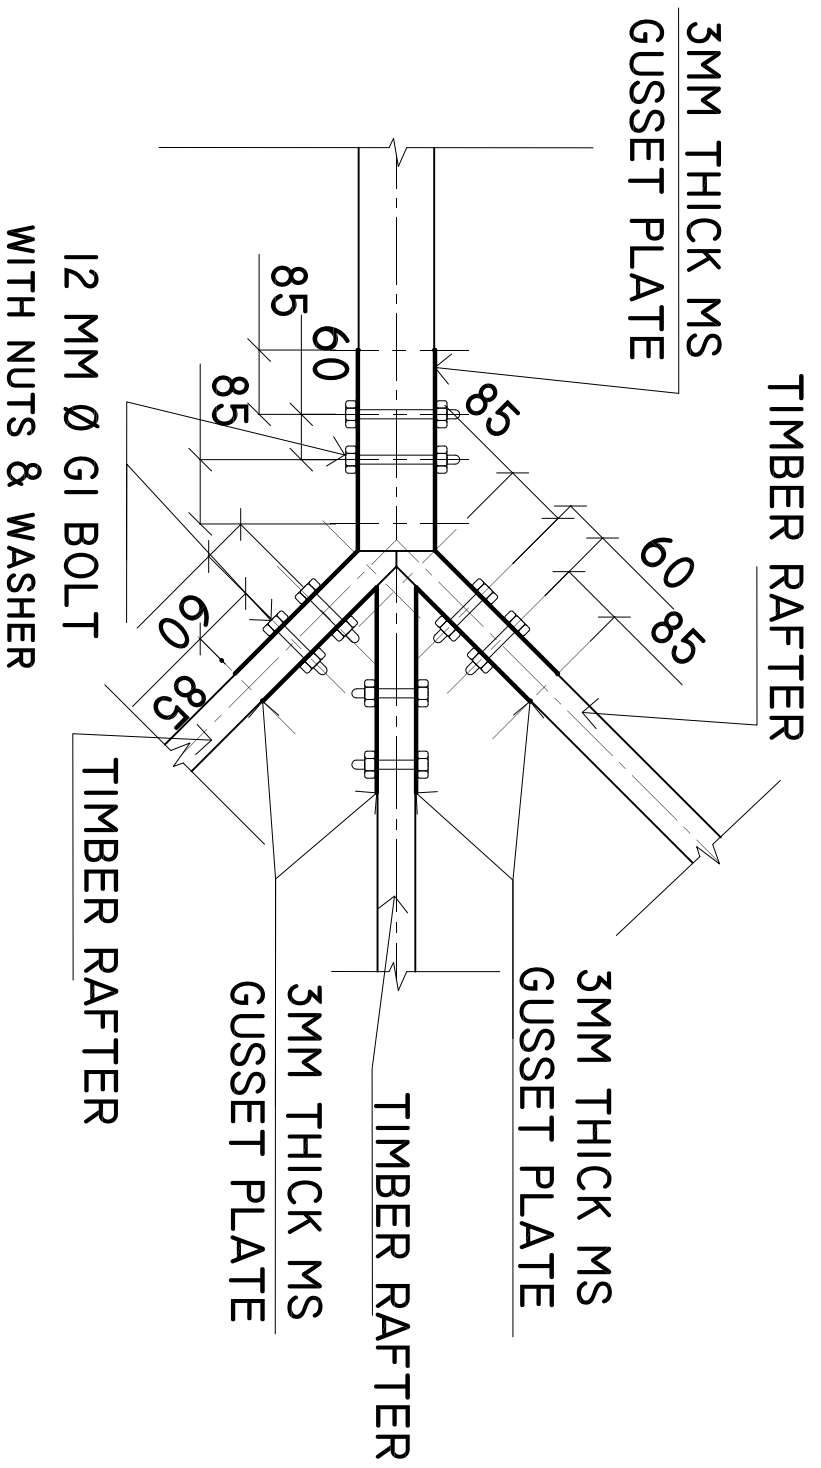

HIP RAFTER CONNECTIO DETAIL

SCALE: 1 : 10

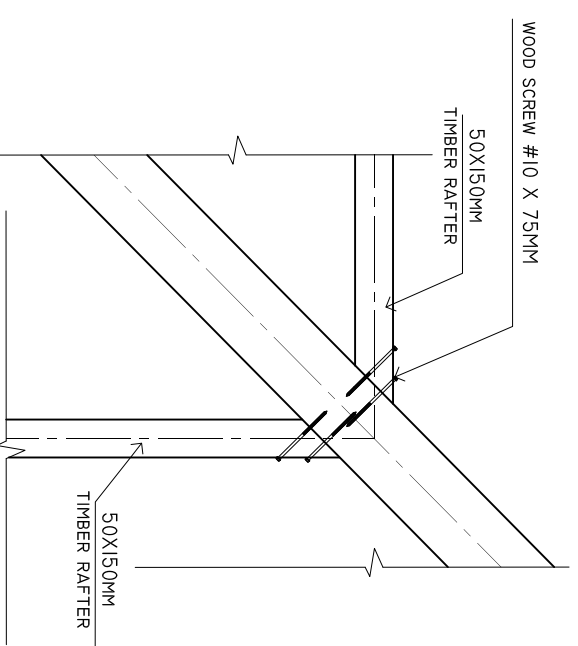

SHEET CONTENTS :

REVISION NOTES:

PROJECT:
CONSTRUCTION OF
AMBULANCE PORTICO

CLIENT:

MINISTRY OF HEALTH

LOCATION:
DIFFERENT ISLANDS

CONTENTS: AS GIVEN

PROJECT MANAGER:

DESIGNER: ARIZ

CIV/STR. ENGINEER:

SURVEYED BY: -

DRAWN BY: ARIZ

CHECKED BY:

DATE : FEBRUARY 2021

SHEET NO. : /

PAPER SIZE: A3



ADMIN DIVISION
Ministry of Health
Roshanae Building
Soana Maaga
Tel: 332 8887, Fax: 332 8889