


GROUND FLOOR PLAN


SCALE 1:100

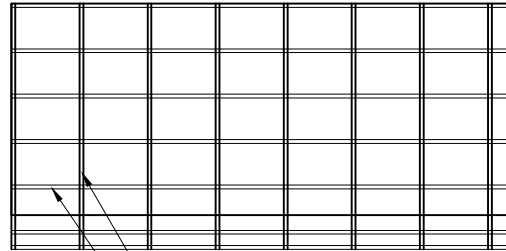

50X100mm c-purlins @ 900C/C
50x25mm steel hollow sections @ 600C/C


ROOF FRAMING PLAN

SCALE 1:100

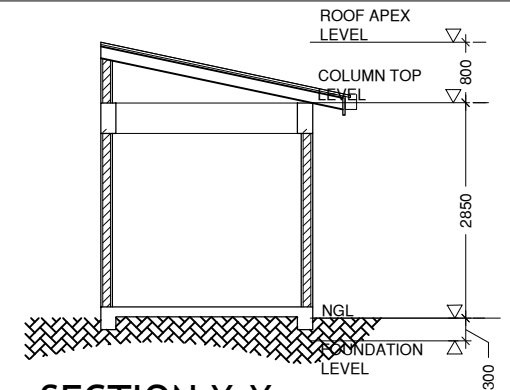

SECTION X:X


SCALE 1:100

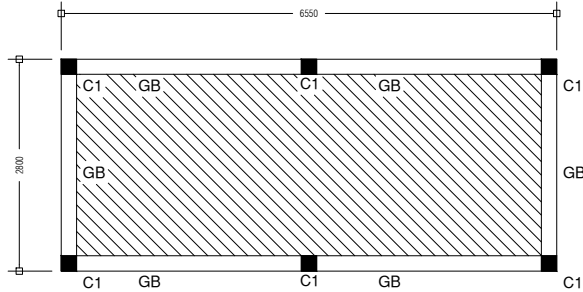

NOTE:
SLAB THICKNESS = 100mm
REINFORCEMENT: T10@150 C/C BW

FOUNDATION PLAN



SCALE 1:100

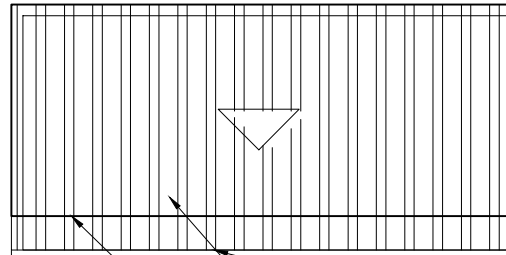

LYSAGHT STANDARD GUTETR
LYSAGHT STANDARD ROOFING SHEETS

ROOF FRAMING PLAN

SCALE 1:100

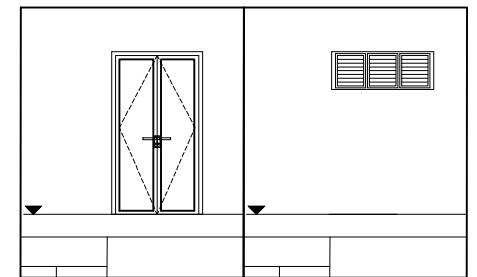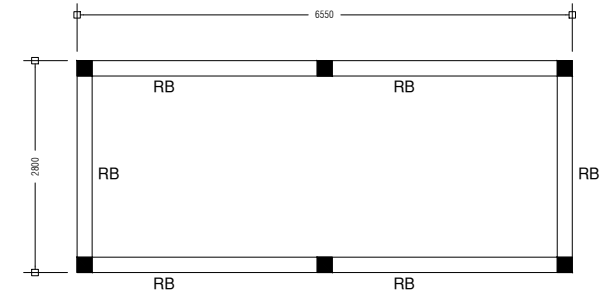

DOORS AND WINDOWS

DISTRIBUTION BOARDS



20W LED LIGHT (DAY LIGHT)



20W WALL MOUNT EXTERIOR LED LIGHT (DAY LIGHT)



10W WALL MOUNT LED EMERGENCY LIGHT (DAY LIGHT)




13AMP DOUBLE SOCKET



3 PHASE, 15A POWER POINTS [1.5m ABOVE FL. LEVEL]



EXHAUST FAN

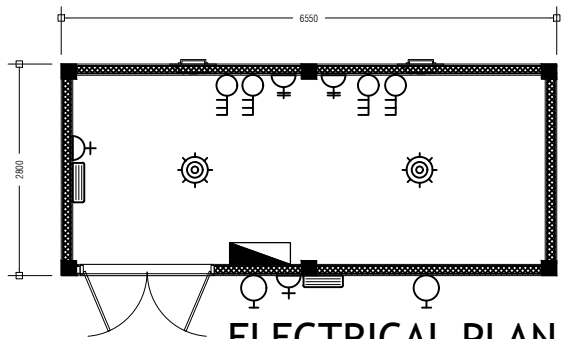

ELECTRICAL PLAN

APPROVED BY



MCEP
MECCT
GREEN BUILDING, HANDHUVAREE HIGUN,
MAAFANNU, MALE (20392), REPUBLIC OF MALDIVES,
TEL: +960-3018431, +960-3018300, FAX: +960-328301

PROJECT

CONSTRUCTION OF FUEL PUMP ROOM
R. VANDHOO

DESIGN BY

AFRAZ

AMENDMENTS

ROOF BEAM PLAN, ELECTRICAL LAYOUT, DOORS AND WINDOWS DETAILS ADDED

TITLE

PLAN AND SECTION

STRUCTURE BY

AFRAZ

CLIENT DEPARTMENT

WMPC DEPARTMENT

DRAWN BY

AFRAZ

PAPER SIZE

A4

SCALE

1:100

PAGE NO.

11

DWG NO.

VNDADFUEL A1-11(R)

DATE

20.03.2023