



KEY PLAN

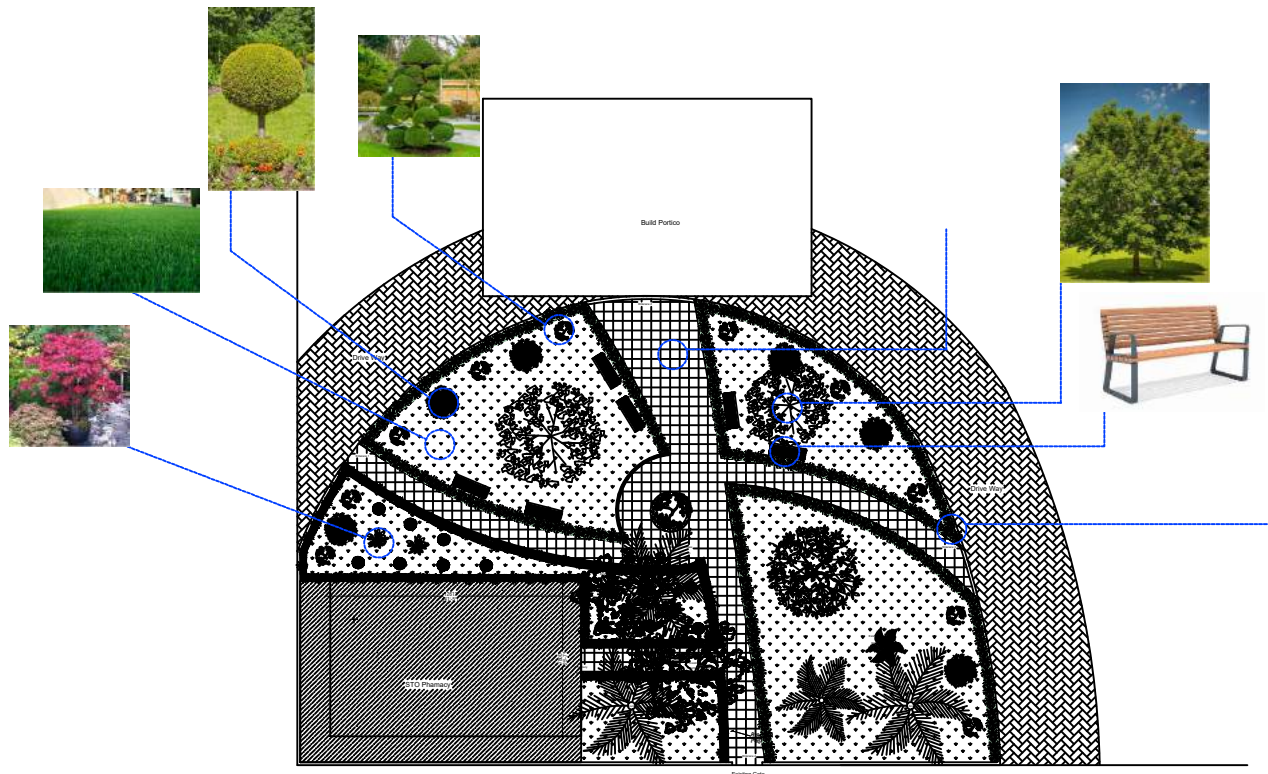

Existing Plan Before Amendment

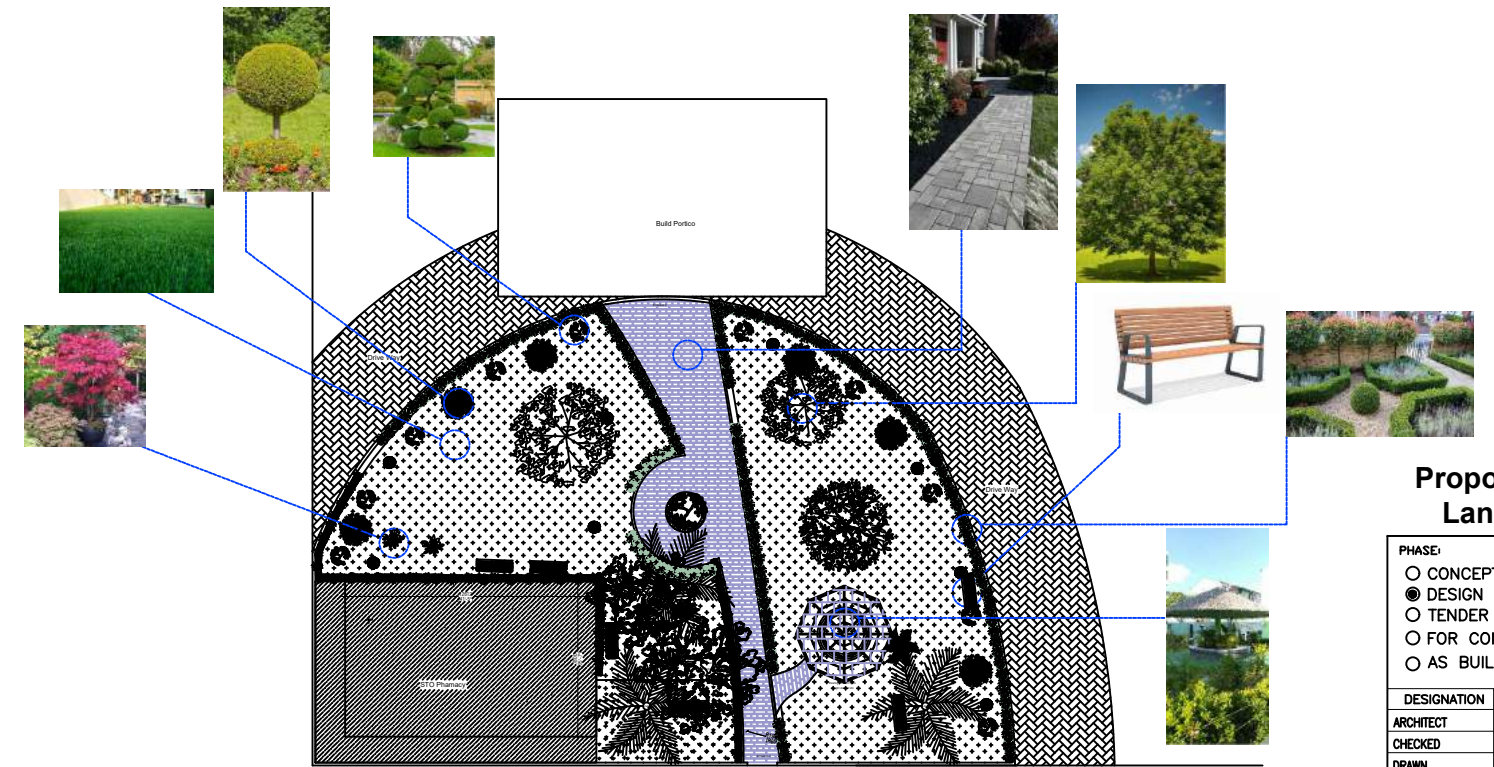

Proposed Plan / After Amendment

Proposed Park Landscape

- PHASE:
- CONCEPT DESIGN
 - DESIGN DEVELOPMENT
 - TENDER DOCUMENT
 - FOR CONSTRUCTION
 - AS BUILD DRAWINGS


DESIGNATION	NAME
ARCHITECT	Nimraah
CHECKED	Aruboon
DRAWN	Nimraah
CLIENT	ASRH

Amendment - 03 (08-04-2023)



CODE	DATE	DWG. NO:
	11-03-2023	01
FORMAT	A1 A2 A3	ISSUE A
SCALE	- - -	
FILE NAME:		



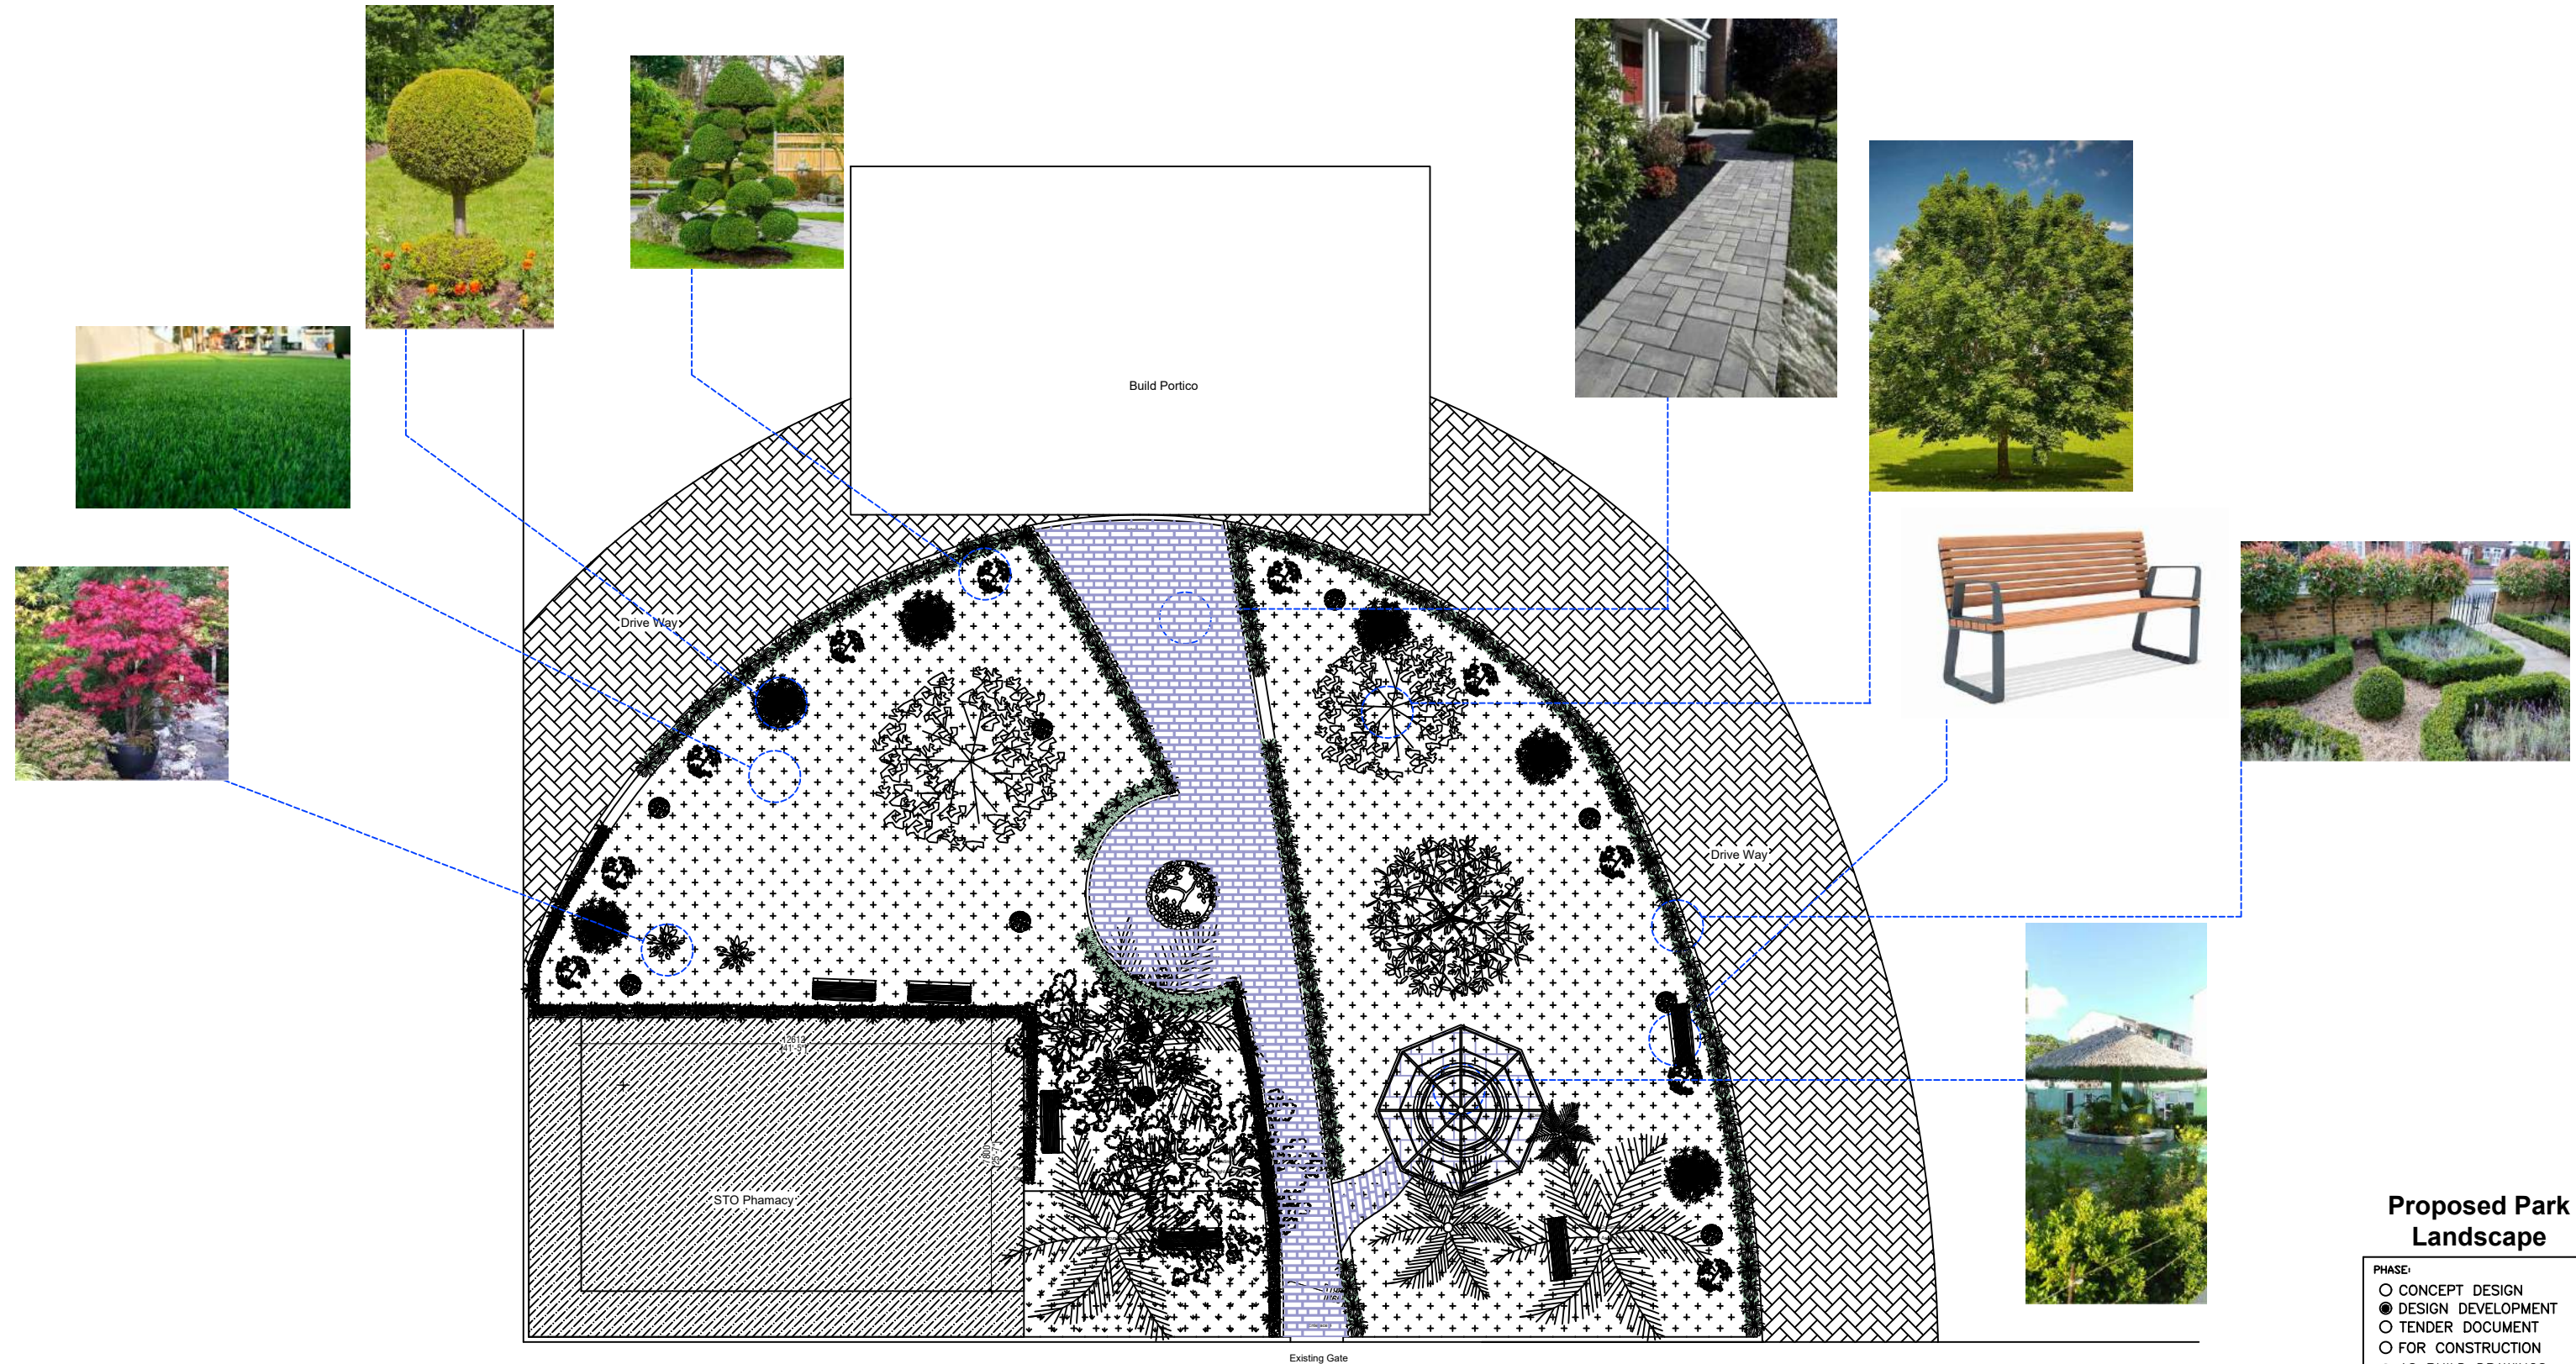

Proposed Park Landscape

- PHASE:
- CONCEPT DESIGN
 - DESIGN DEVELOPMENT
 - TENDER DOCUMENT
 - FOR CONSTRUCTION
 - AS BUILD DRAWINGS


DESIGNATION	NAME
ARCHITECT	Nimreesh
CHECKED	Aruban
DRAWN	Nimreesh
CLIENT	ASMH

Amendment - 03 (08-04-2023)





NEEMRANA
Pvt. Ltd.

CODE	DATE	DWG. NO:
	11-03-2023	02
FORMAT	A1 A2 A3	ISSUE A
SCALE	- - -	
FILE NAME:		

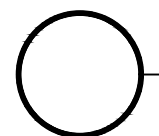

CONCEPT DESIGN LAYOUT

1:100

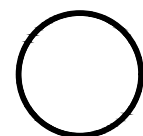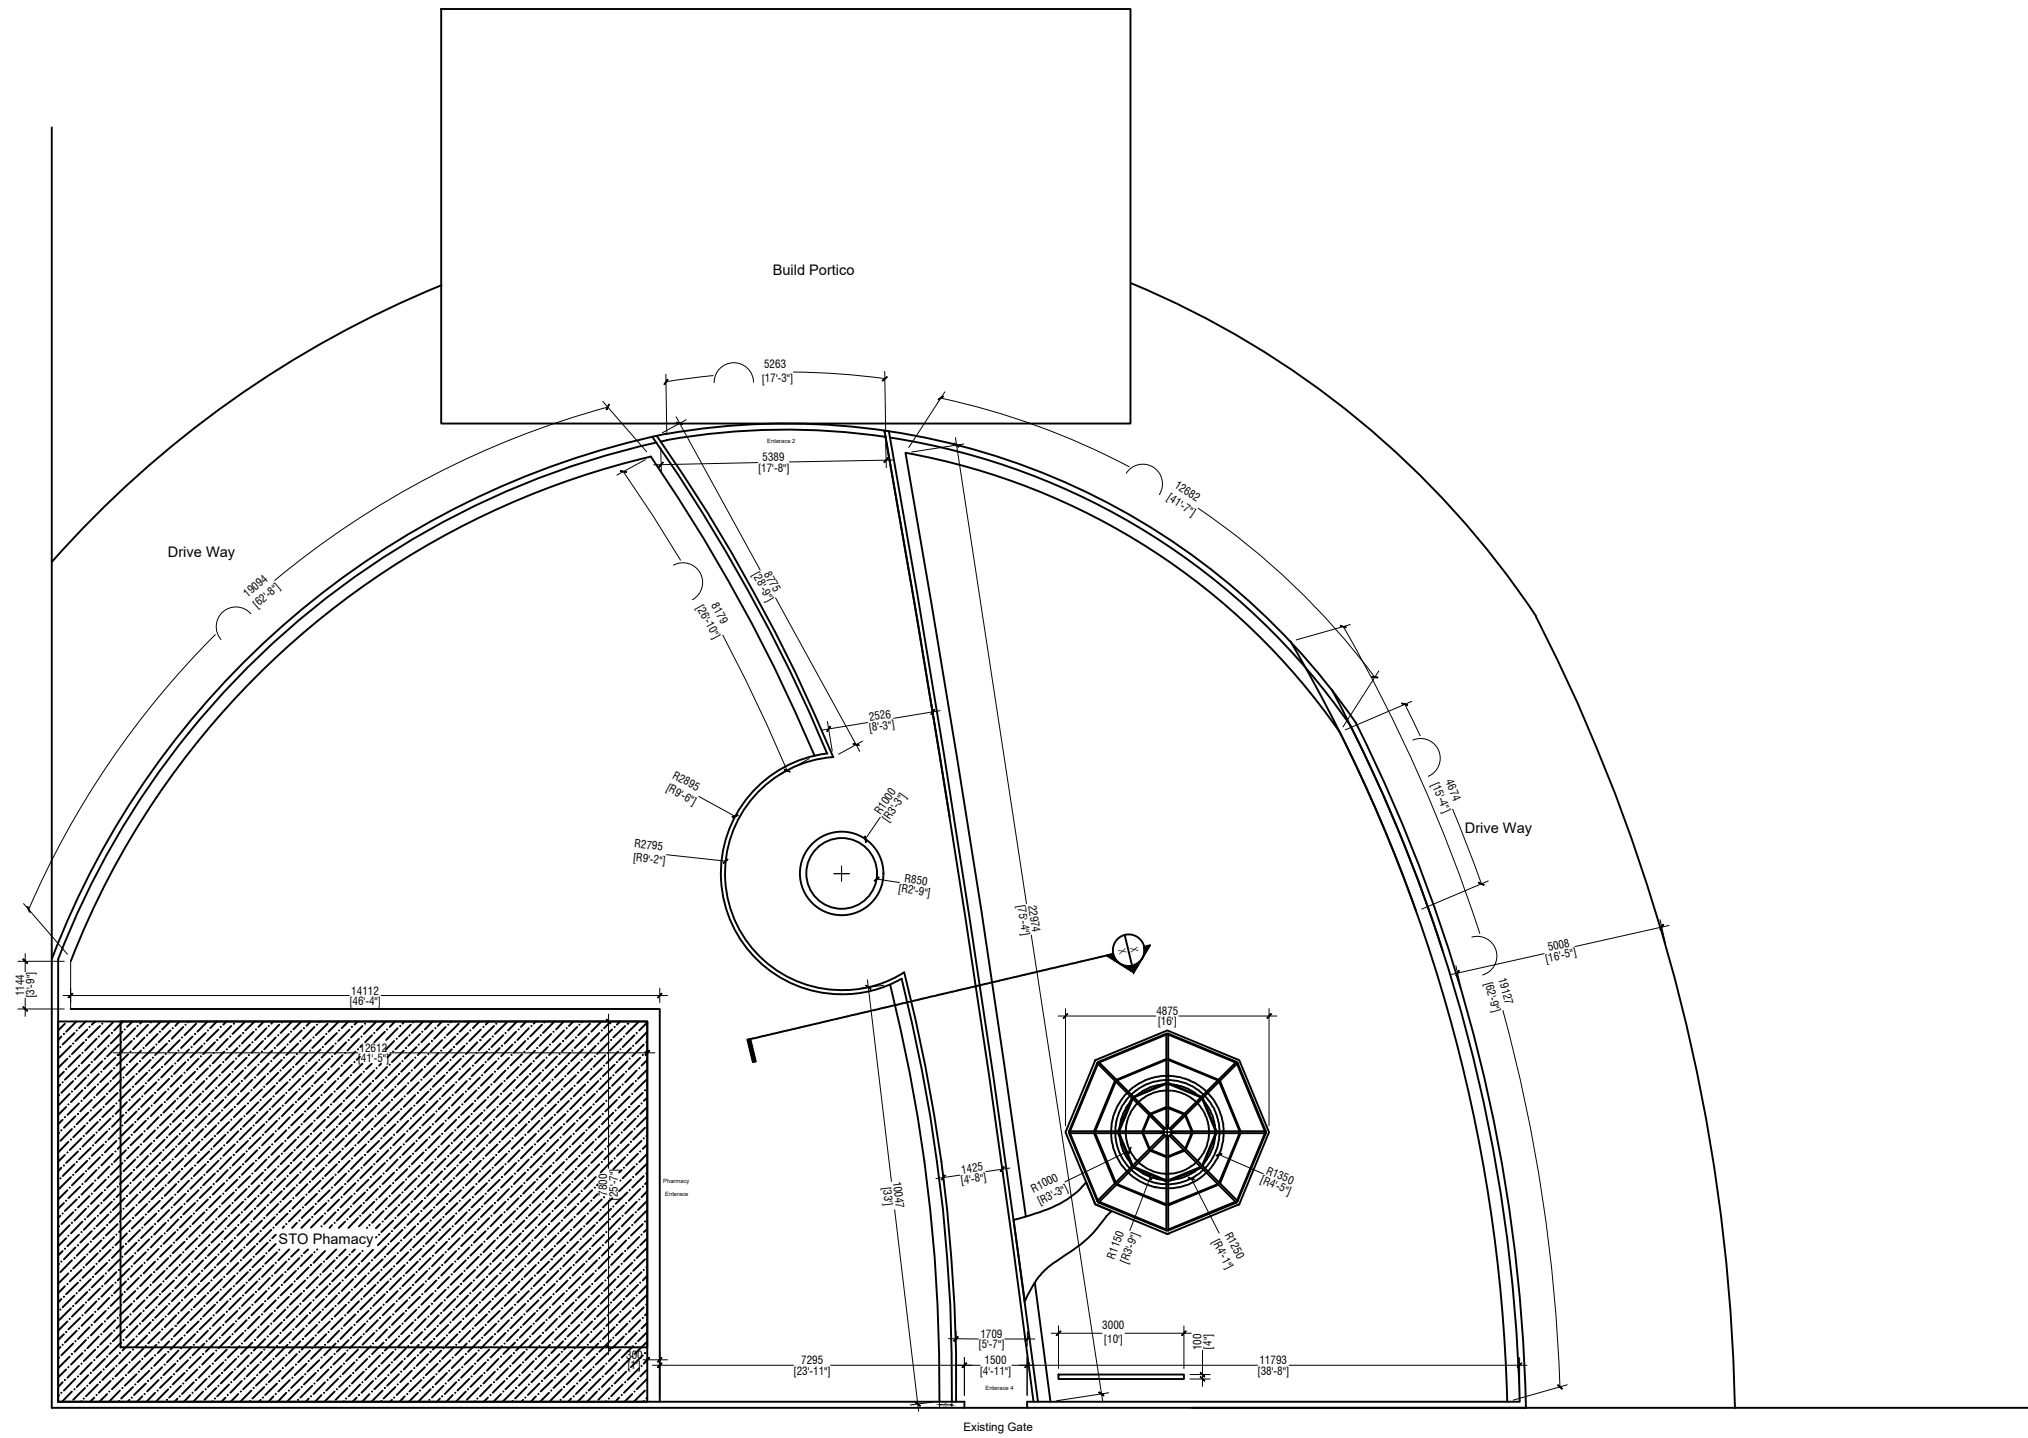

DIMENSION LAYOUT

1:100

Proposed Park Landscape

- PHASE:
- CONCEPT DESIGN
 - DESIGN DEVELOPMENT
 - TENDER DOCUMENT
 - FOR CONSTRUCTION
 - AS BUILD DRAWINGS


DESIGNATION	NAME
ARCHITECT	Nimreesh
CHECKED	Aruban
DRAWN	Nimreesh
CLIENT	ASMH

Amendment - 03 (08-04-2023)




NEEMRANA
Pvt. Ltd.

CODE	DATE	DWG. NO:
	11-03-2023	03
FORMAT	A1 A2 A3	ISSUE A
SCALE	- - -	
FILE NAME:		

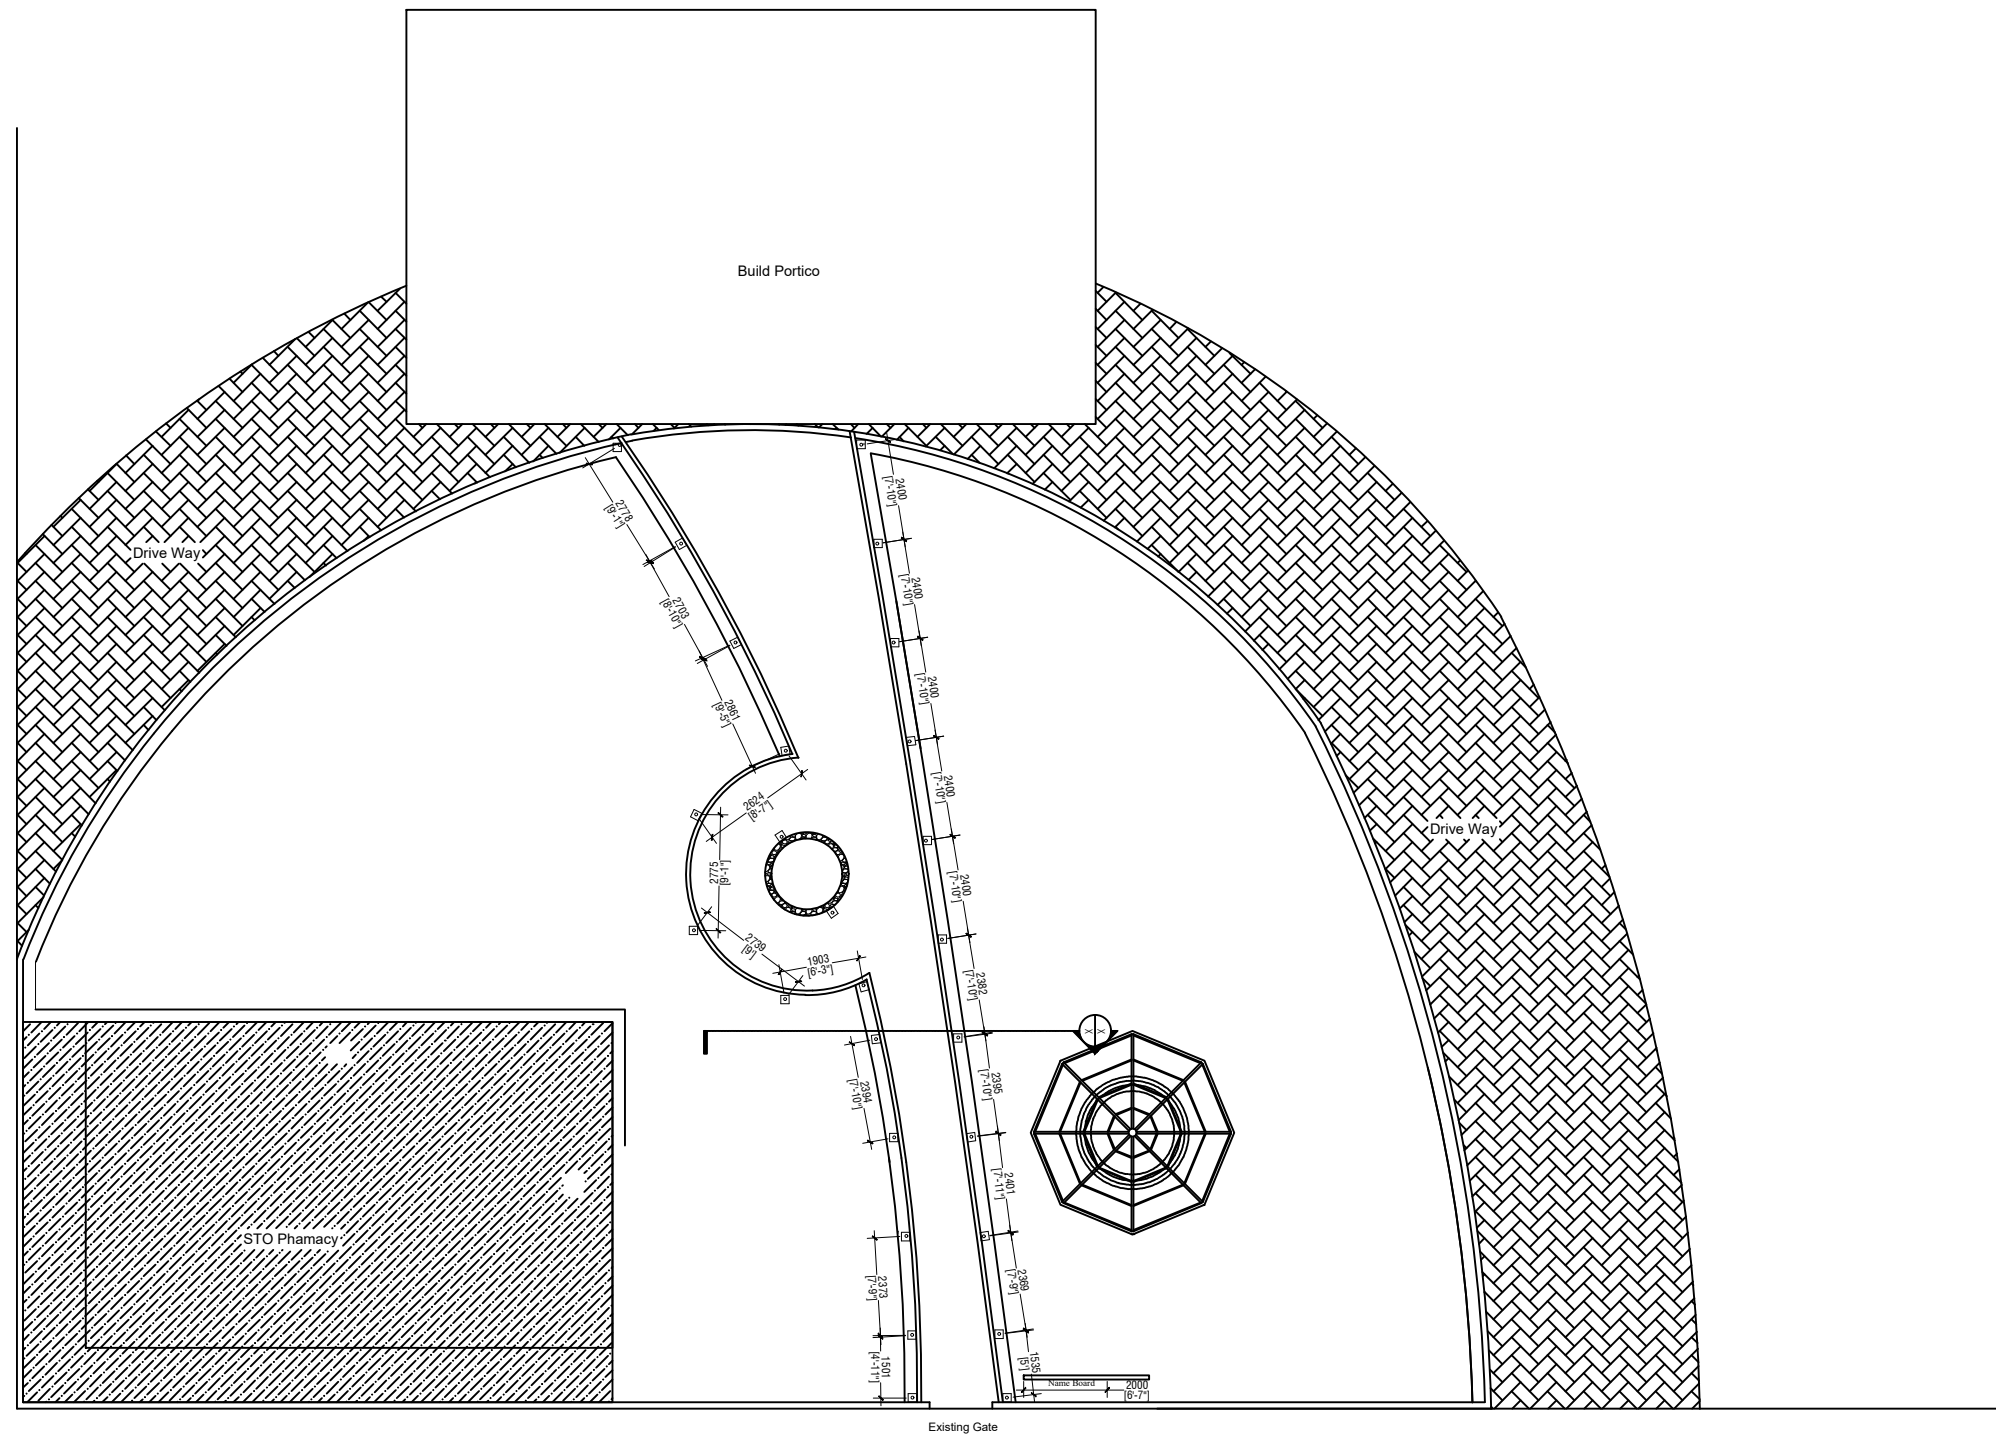

Note:- Columns Size
200x200x400mm Mass
Concrete

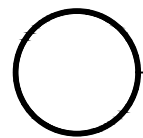

COLUMNS SETTING LAYOUT

1:100

Proposed Park Landscape

- PHASE:
- CONCEPT DESIGN
 - DESIGN DEVELOPMENT
 - TENDER DOCUMENT
 - FOR CONSTRUCTION
 - AS BUILD DRAWINGS



DESIGNATION	NAME
ARCHITECT	Nimreesh
CHECKED	Aruban
DRAWN	Nimreesh
CLIENT	ASMH

Amendment - 03 (08-04-2023)



NEEMRANA
Pvt. Ltd.

CODE	DATE	DWG. NO:
	11-03-2023	04
FORMAT	A1 A2 A3	
SCALE	- - -	ISSUE A
FILE NAME:		

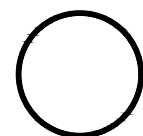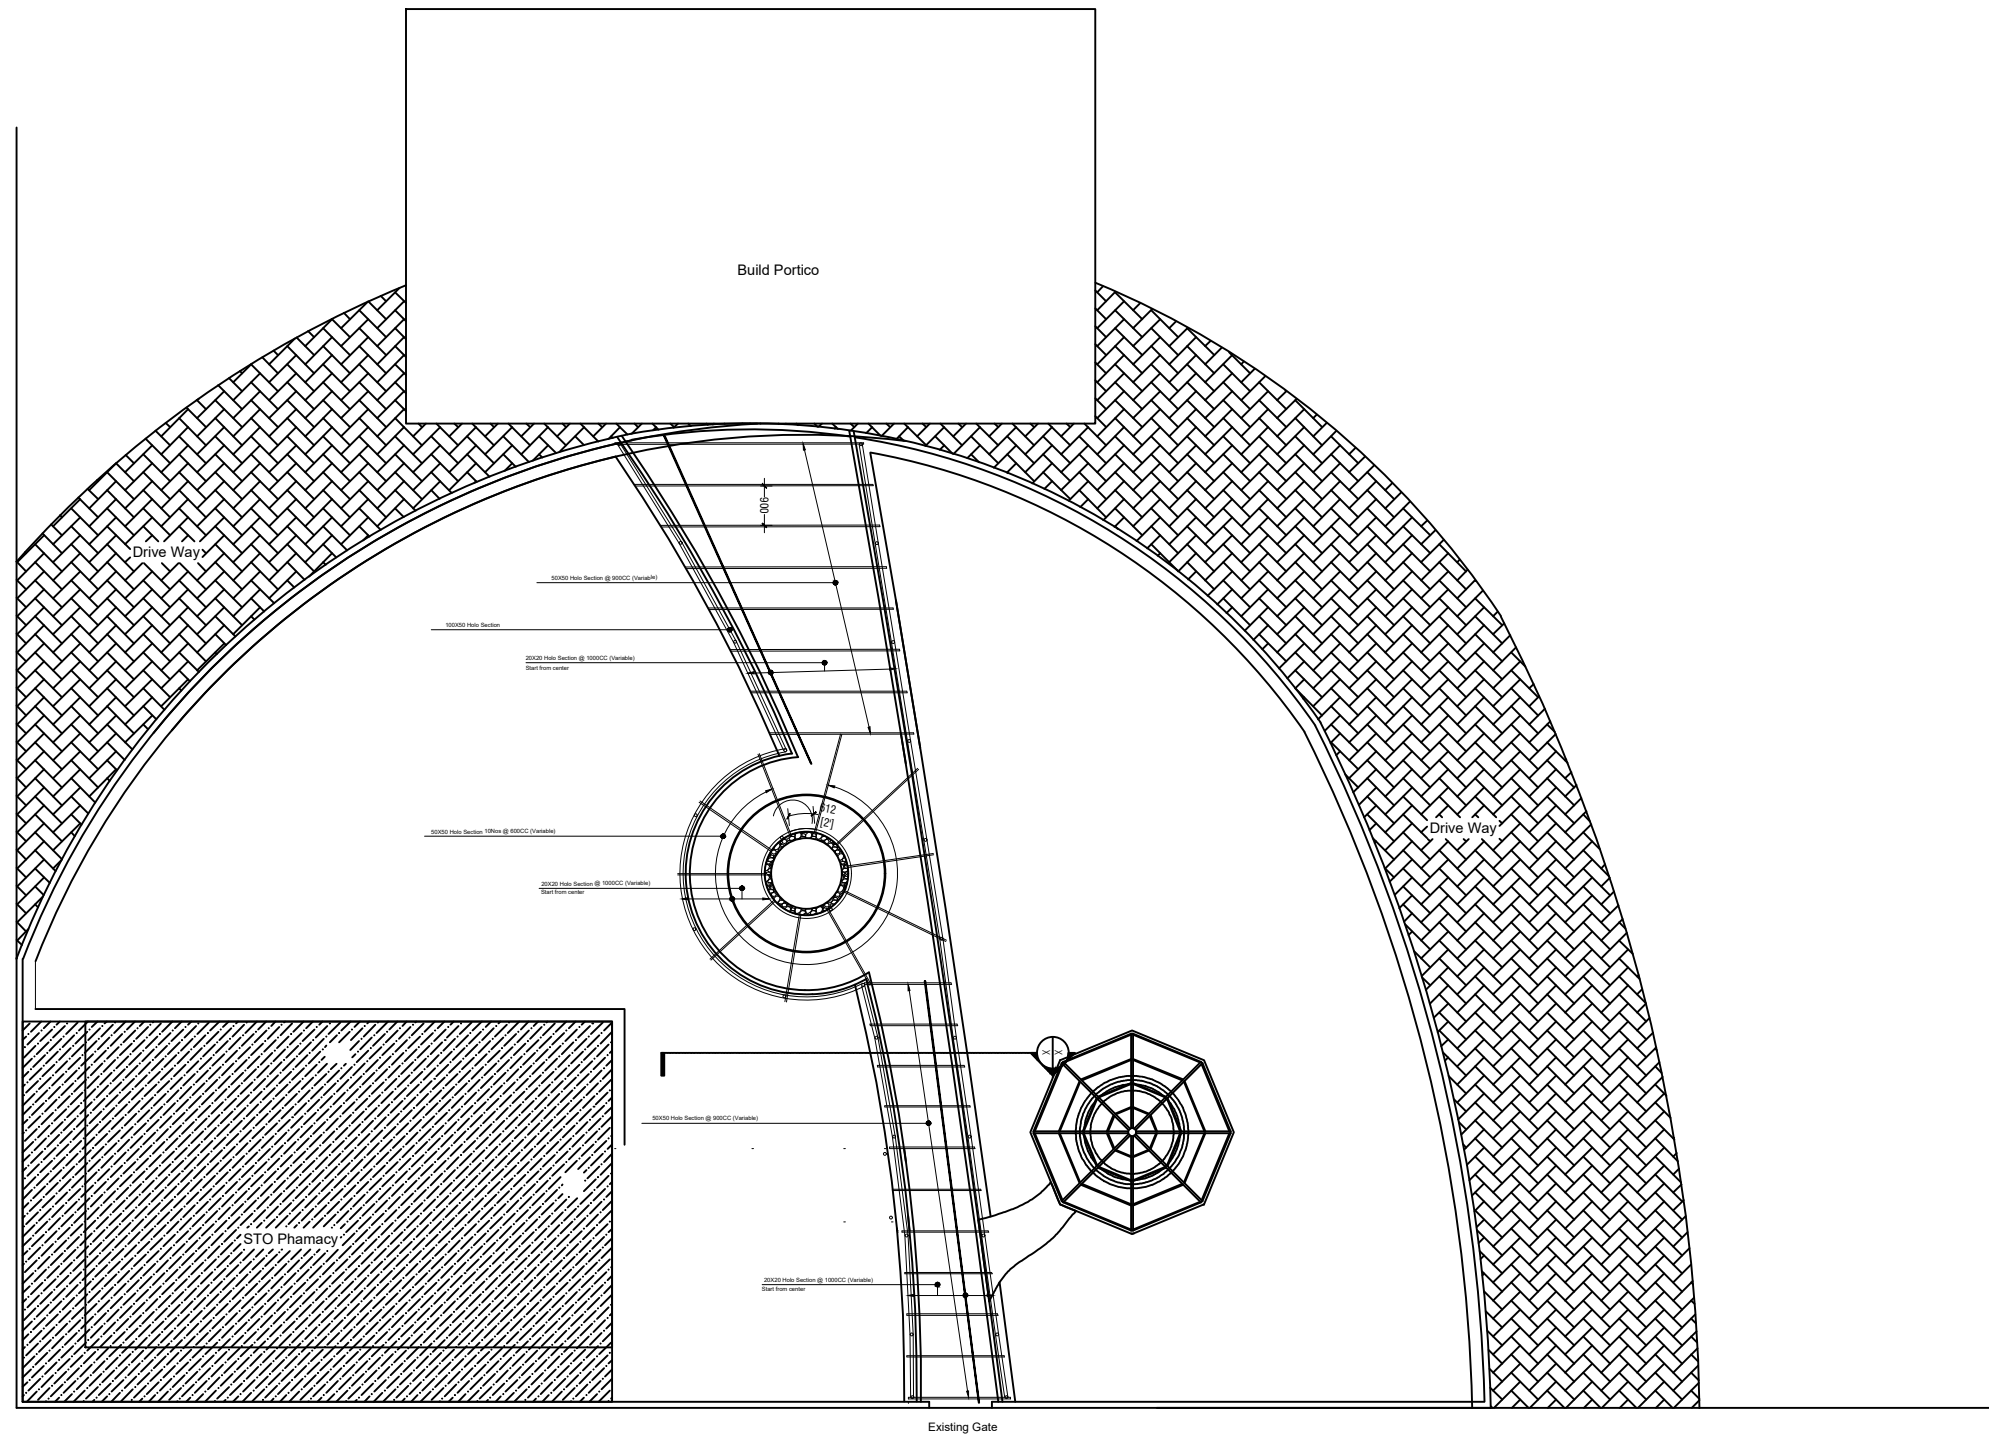

ROOF FRAMING LAYOUT

1:100

Proposed Park Landscape

- PHASE:
- CONCEPT DESIGN
 - DESIGN DEVELOPMENT
 - TENDER DOCUMENT
 - FOR CONSTRUCTION
 - AS BUILD DRAWINGS



DESIGNATION	NAME
ARCHITECT	Nimreesh
CHECKED	Aruban
DRAWN	Nimreesh
CLIENT	ASMH

Amendment - 03 (08-04-2023)



NEEMRANA
Pvt. Ltd.

CODE	DATE	DWG. NO:
	11-03-2023	05
FORMAT	A1 A2 A3	ISSUE A
SCALE	- - -	
FILE NAME:		

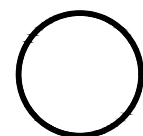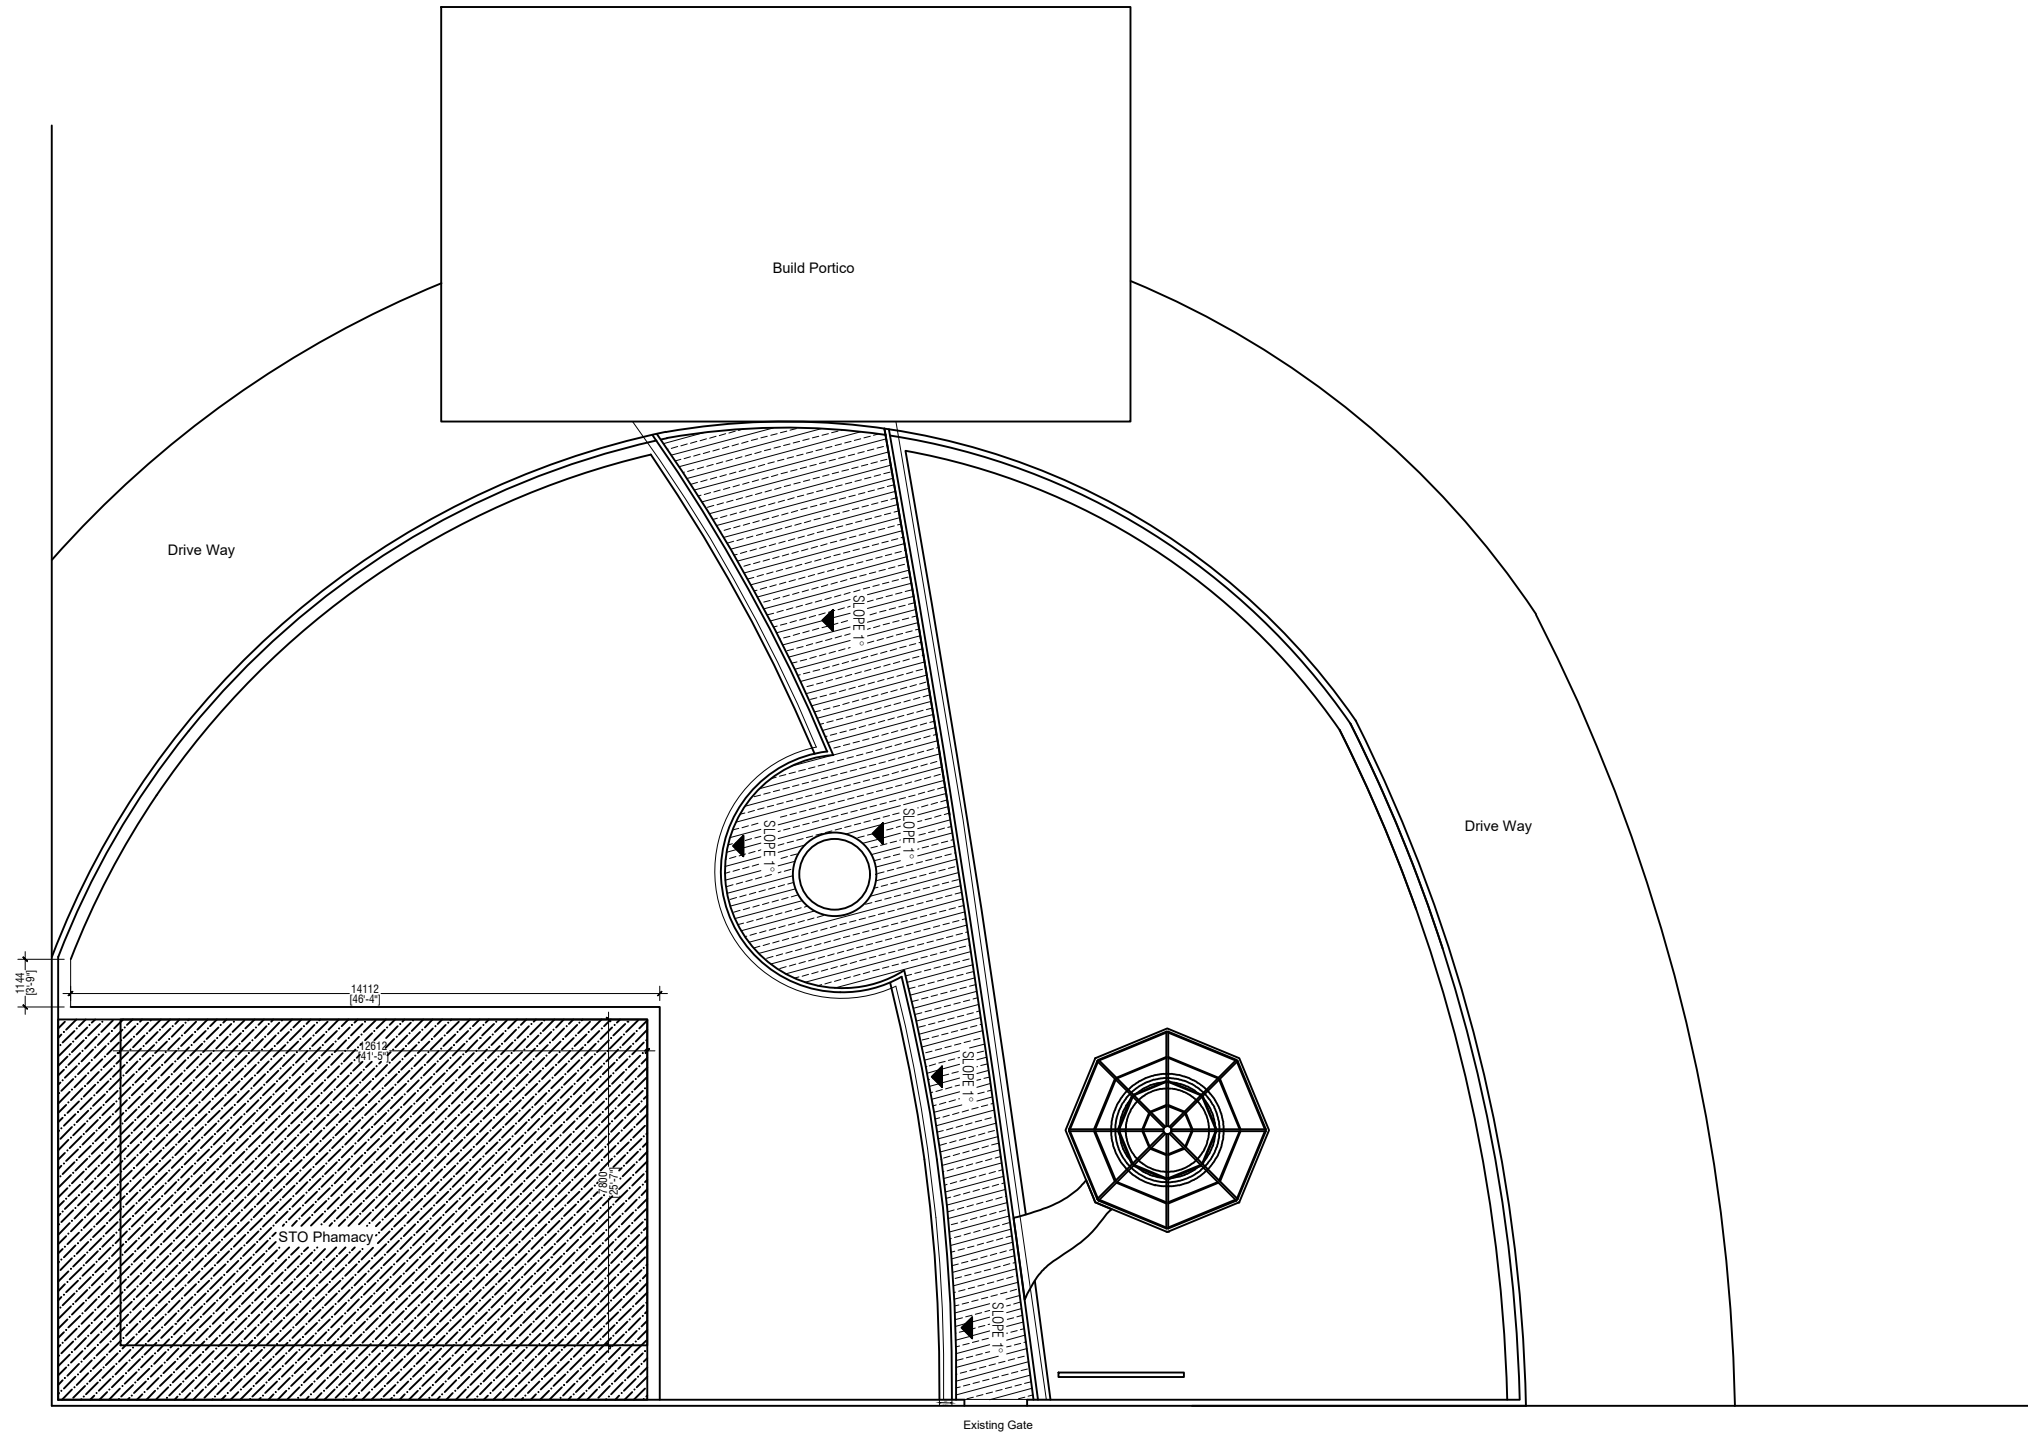

DIMENSION LAYOUT

1:100

Proposed Park Landscape

- PHASE:
- CONCEPT DESIGN
 - DESIGN DEVELOPMENT
 - TENDER DOCUMENT
 - FOR CONSTRUCTION
 - AS BUILD DRAWINGS




DESIGNATION	NAME
ARCHITECT	Nimreesh
CHECKED	Aruban
DRAWN	Nimreesh
CLIENT	ASMH


Amendment - 03 (08-04-2023)



NEEMRANA
Pvt. Ltd.

CODE	DATE	DWG. NO:
	11-03-2023	06
FORMAT	A1 A2 A3	
SCALE	- - -	ISSUE A
FILE NAME:		

LEGEND	DESCRIPTION
	DISTRIBUTION BOARD
	Outdoor Lighting Garden Light Pole
	Ground Sport Light

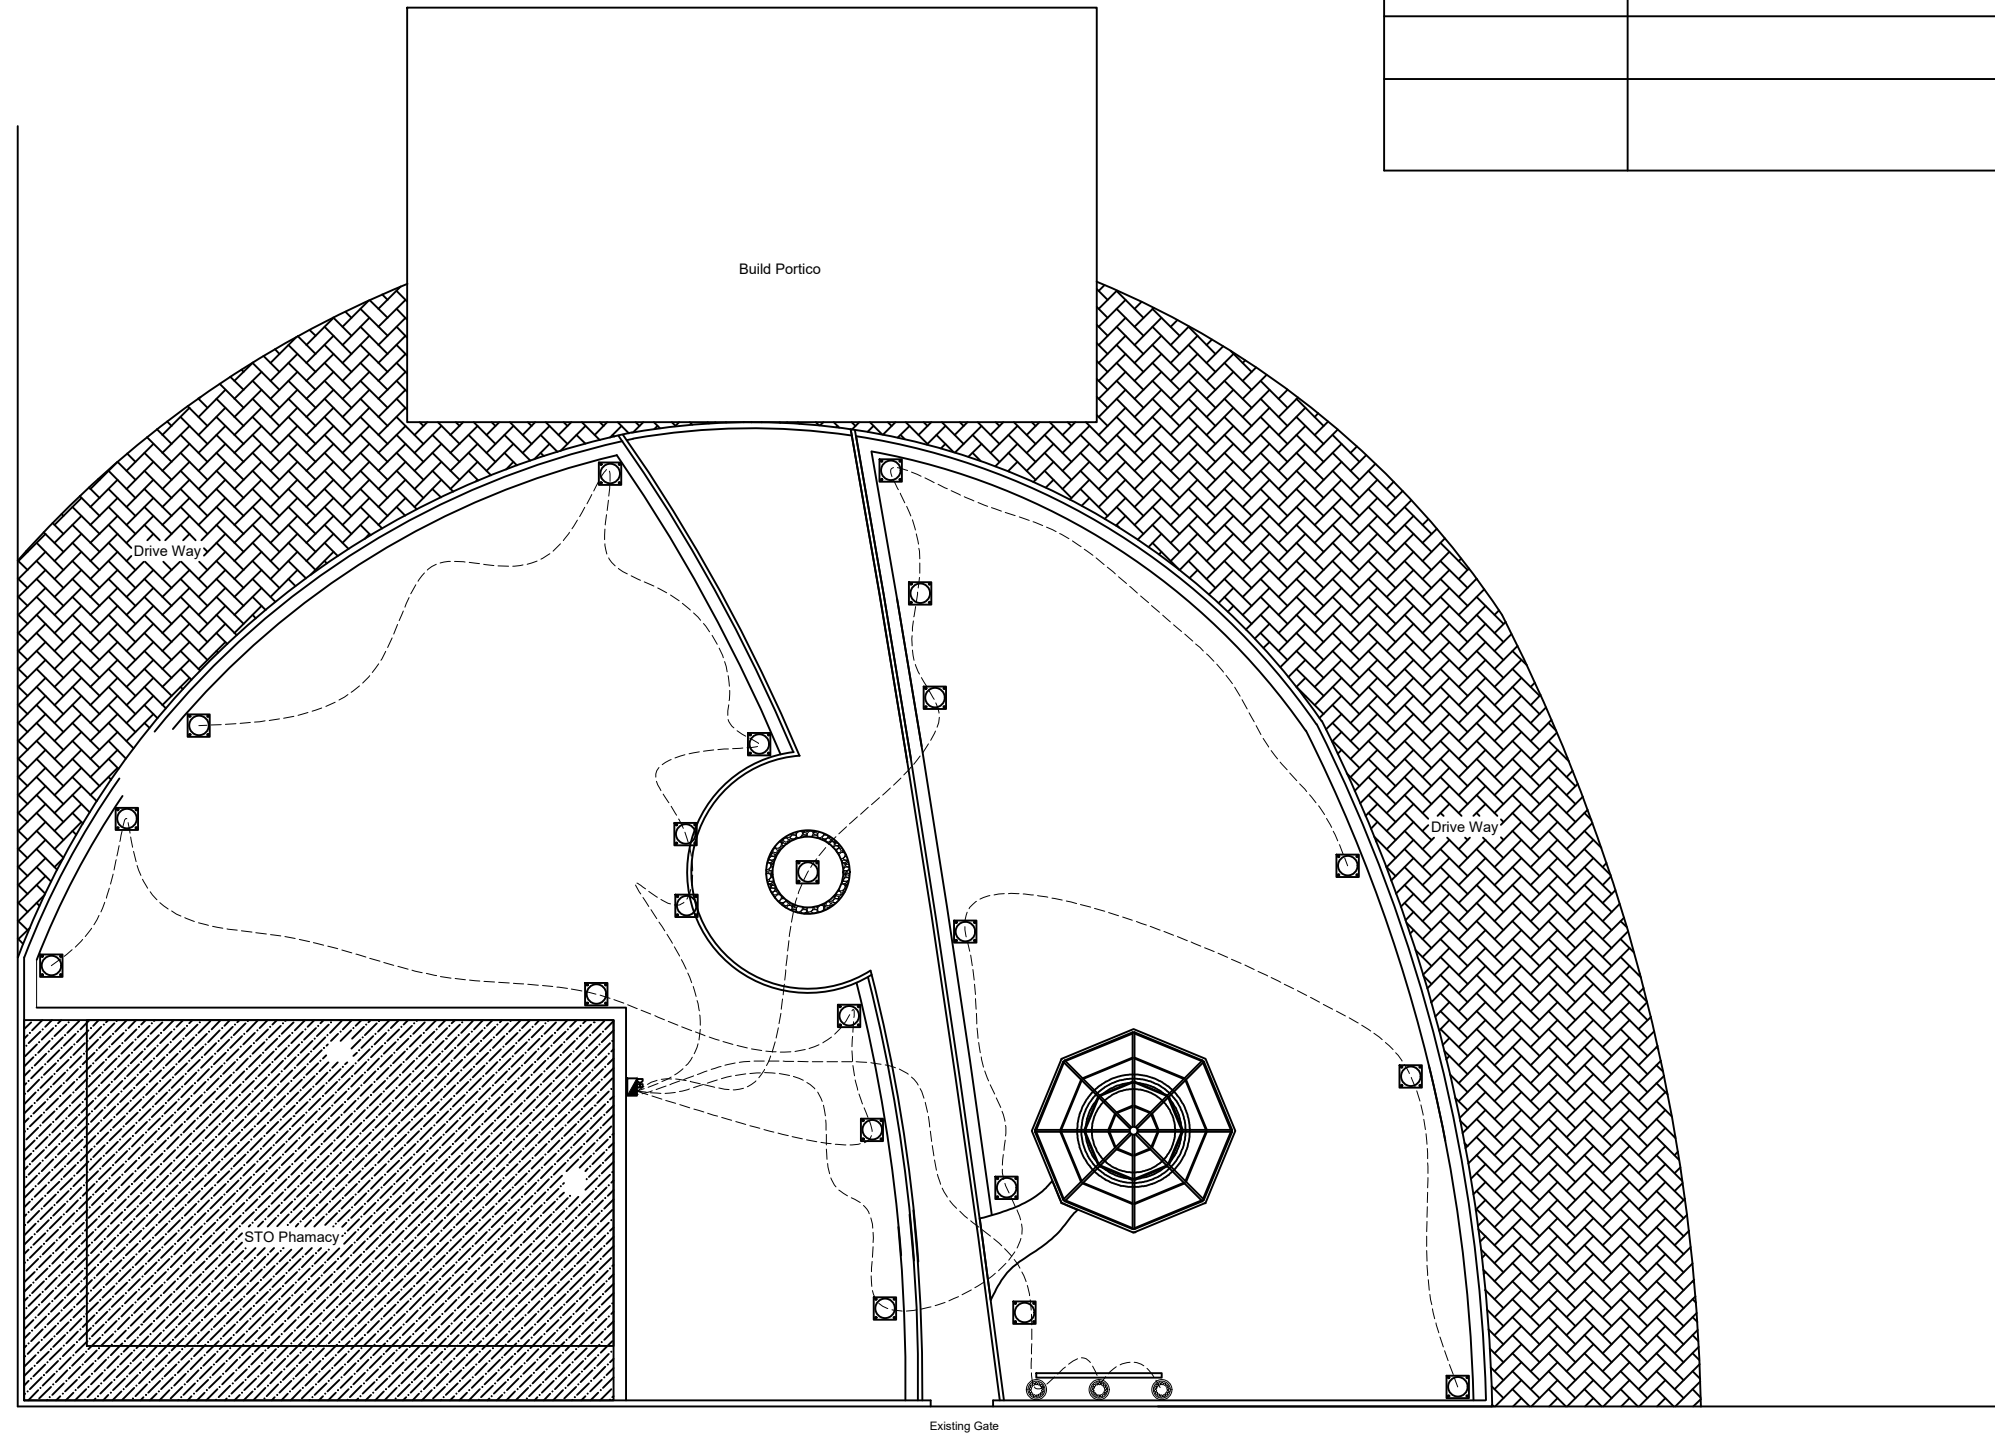


Proposed Park Landscape

- PHASE:
- CONCEPT DESIGN
 - DESIGN DEVELOPMENT
 - TENDER DOCUMENT
 - FOR CONSTRUCTION
 - AS BUILD DRAWINGS

DESIGNATION	NAME
ARCHITECT	Nimreesh
CHECKED	Aruban
DRAWN	Nimreesh
CLIENT	ASMH

Amendment - 03 (08-04-2023)




NEEMRANA
Pvt. Ltd.

CODE	DATE	DWG. NO:
	11-03-2023	07
FORMAT	A1 A2 A3	ISSUE A
SCALE	- - -	
FILE NAME:		

ELECTRICAL LAYOUT

1:100

LEGEND	DESCRIPTION
	Water Outlet in cluding valve or tep
	Meter
	Ground Water Line

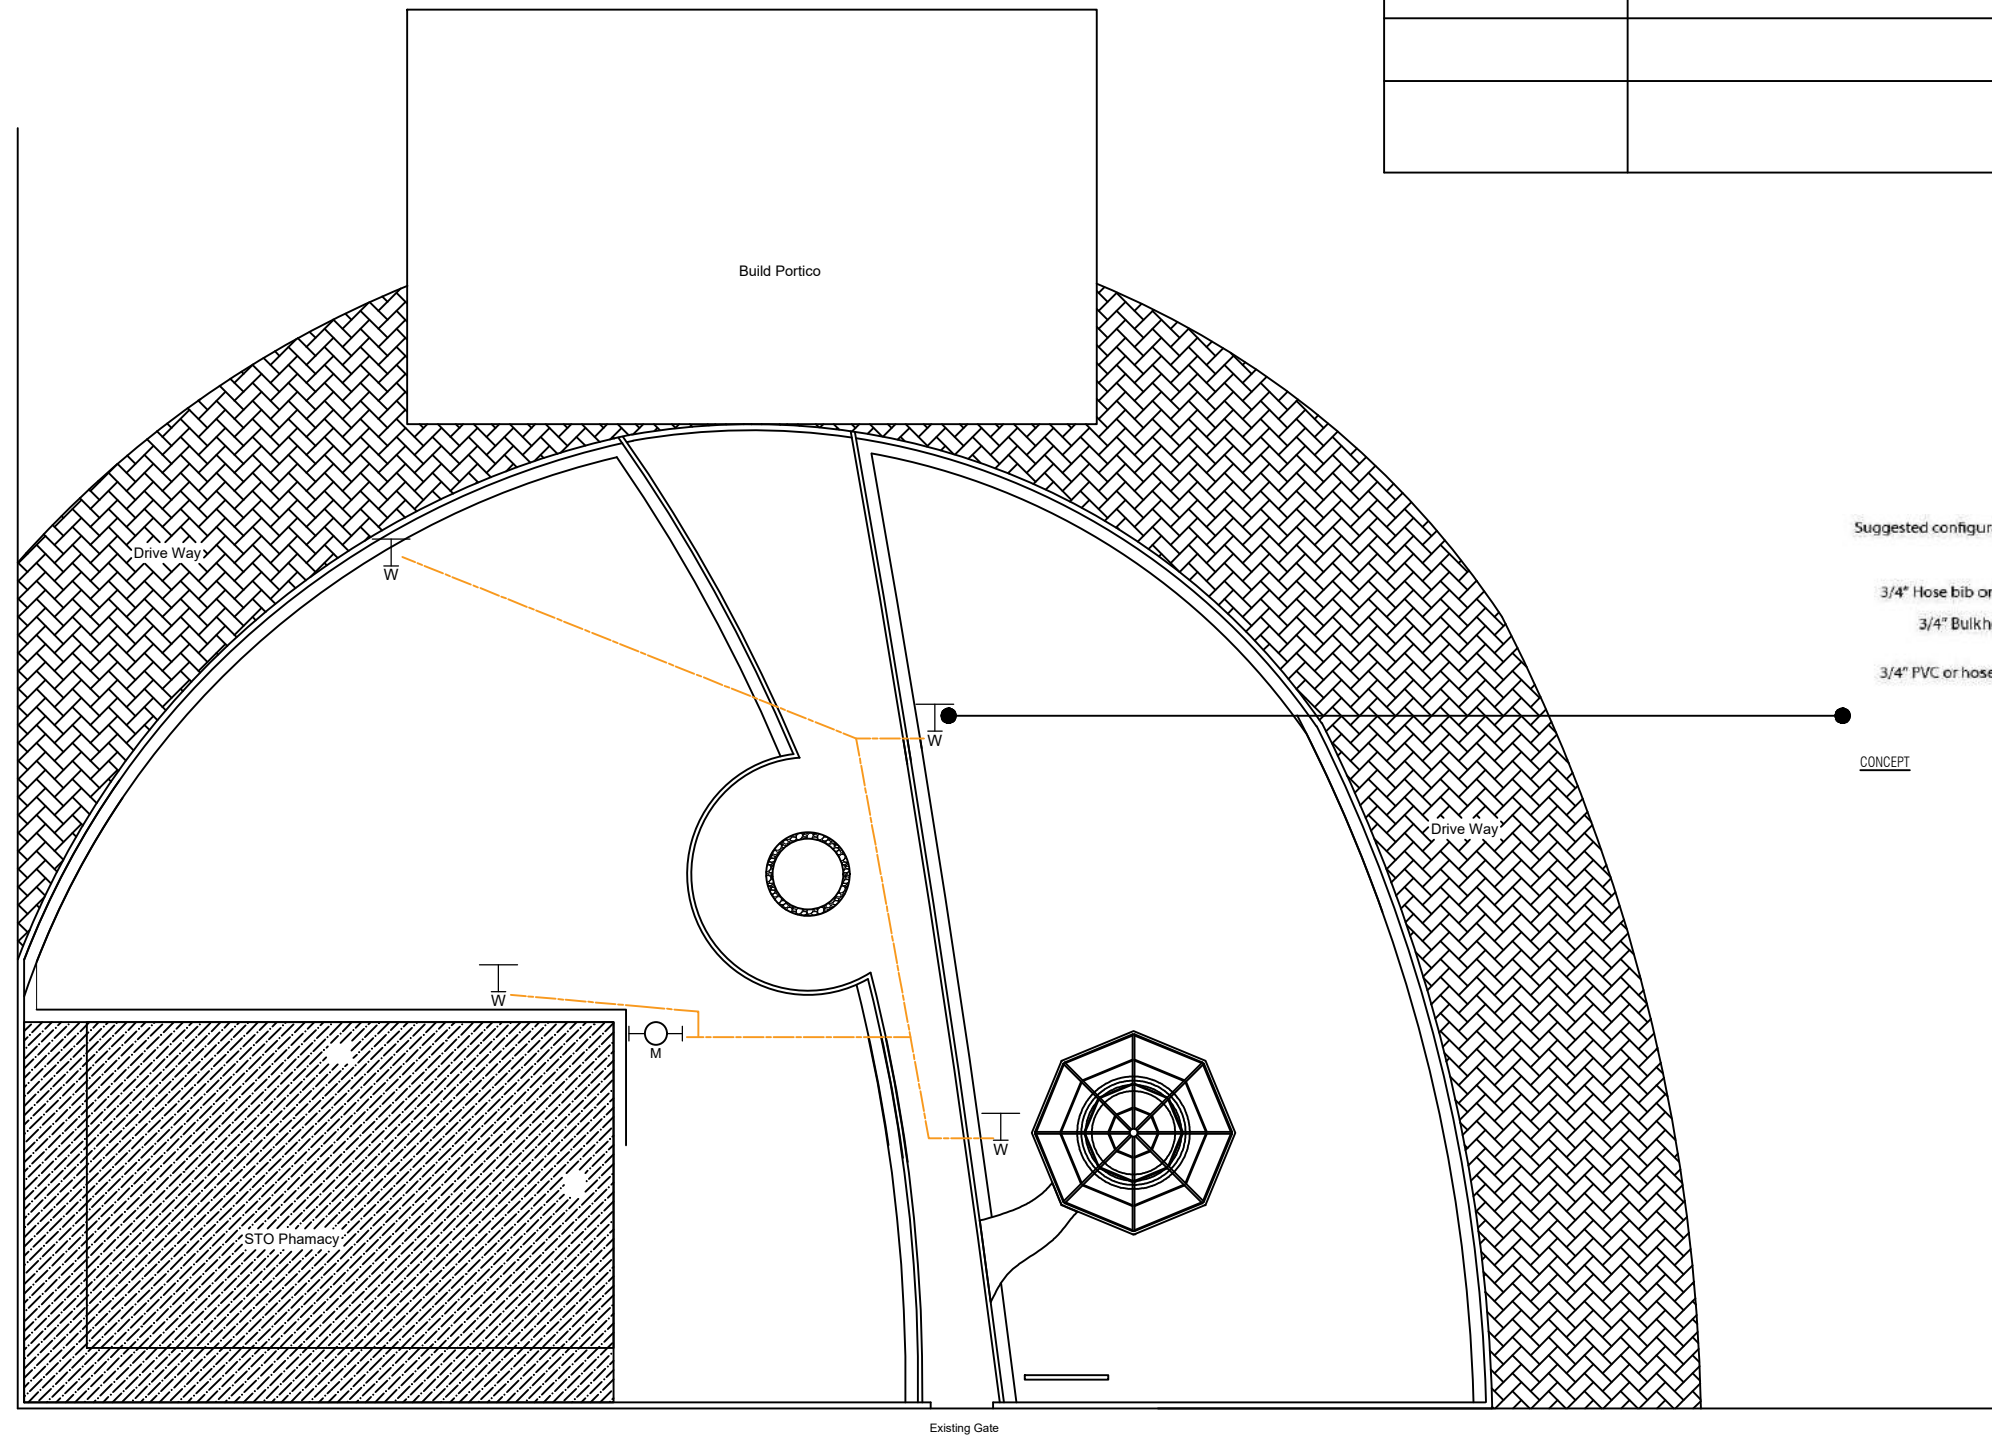

Suggested configuration:

- 3/4" Hose bib or "Y" fitting
- 3/4" Bulkhead fitting
- 3/4" PVC or hose to source



CONCEPT

Proposed Park Landscape

- PHASE:
- CONCEPT DESIGN
 - DESIGN DEVELOPMENT
 - TENDER DOCUMENT
 - FOR CONSTRUCTION
 - AS BUILD DRAWINGS


DESIGNATION	NAME
ARCHITECT	Nimreesh
CHECKED	Aruban
DRAWN	Nimreesh
CLIENT	ASMH

Amendment - 03 (08-04-2023)






NEEMRANA
Pvt. Ltd.

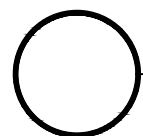
CODE	DATE	DWG. NO:
	11-03-2023	08
FORMAT	A1 A2 A3	ISSUE A
SCALE	- - -	
FILE NAME:		



PLUMBING LAYOUT

1:100

LEGEND	DESCRIPTION
	OUTDOOR DB BOX
	Outdoor Lighting Garden Light Pole
	Ground Sport Light

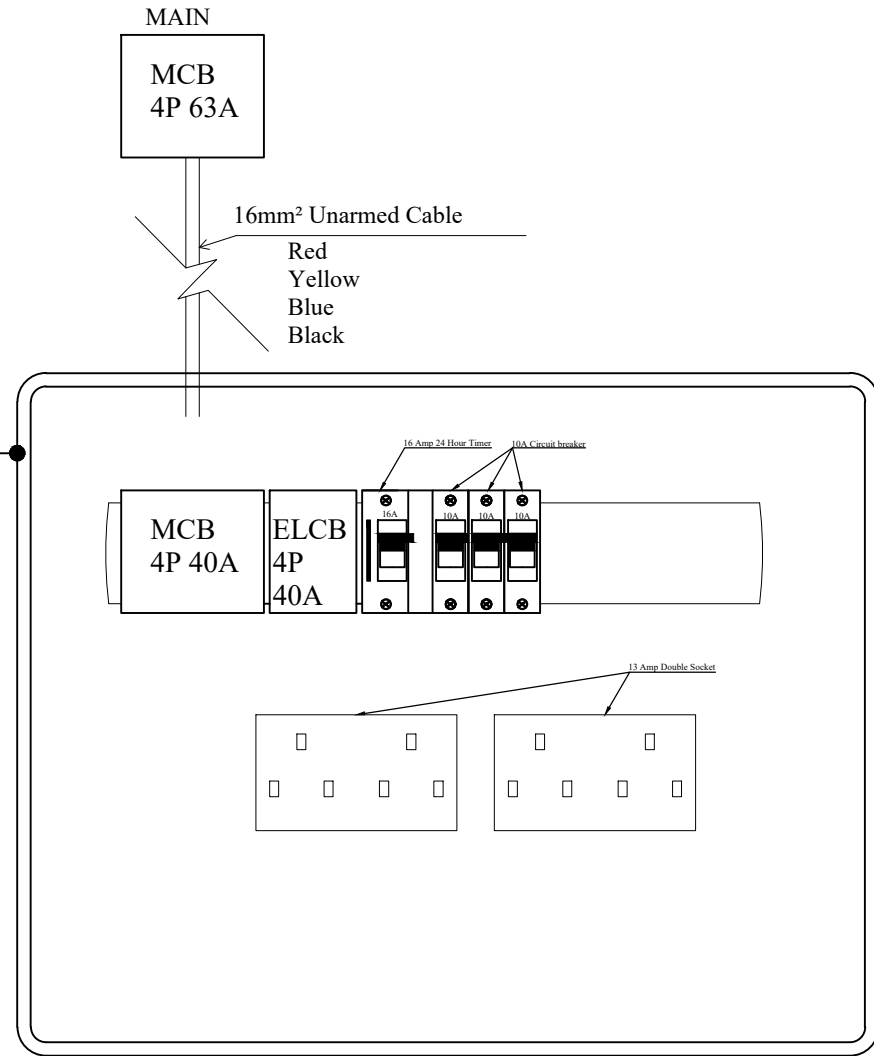

Outdoor DB and Main Cable Cable Diagram

ELECTRICAL LEGEND

1:100

Proposed Park Landscape


- PHASE:
- CONCEPT DESIGN
 - DESIGN DEVELOPMENT
 - TENDER DOCUMENT
 - FOR CONSTRUCTION
 - AS BUILD DRAWINGS

DESIGNATION	NAME
ARCHITECT	Nimreesh
CHECKED	Aruban
DRAWN	Nimreesh
CLIENT	ASMH

Amendment - 03 (08-04-2023)



CODE	DATE	DWG. NO:
	11-03-2023	09
FORMAT	A1 A2 A3	ISSUE A
SCALE	- - -	
FILE NAME:		

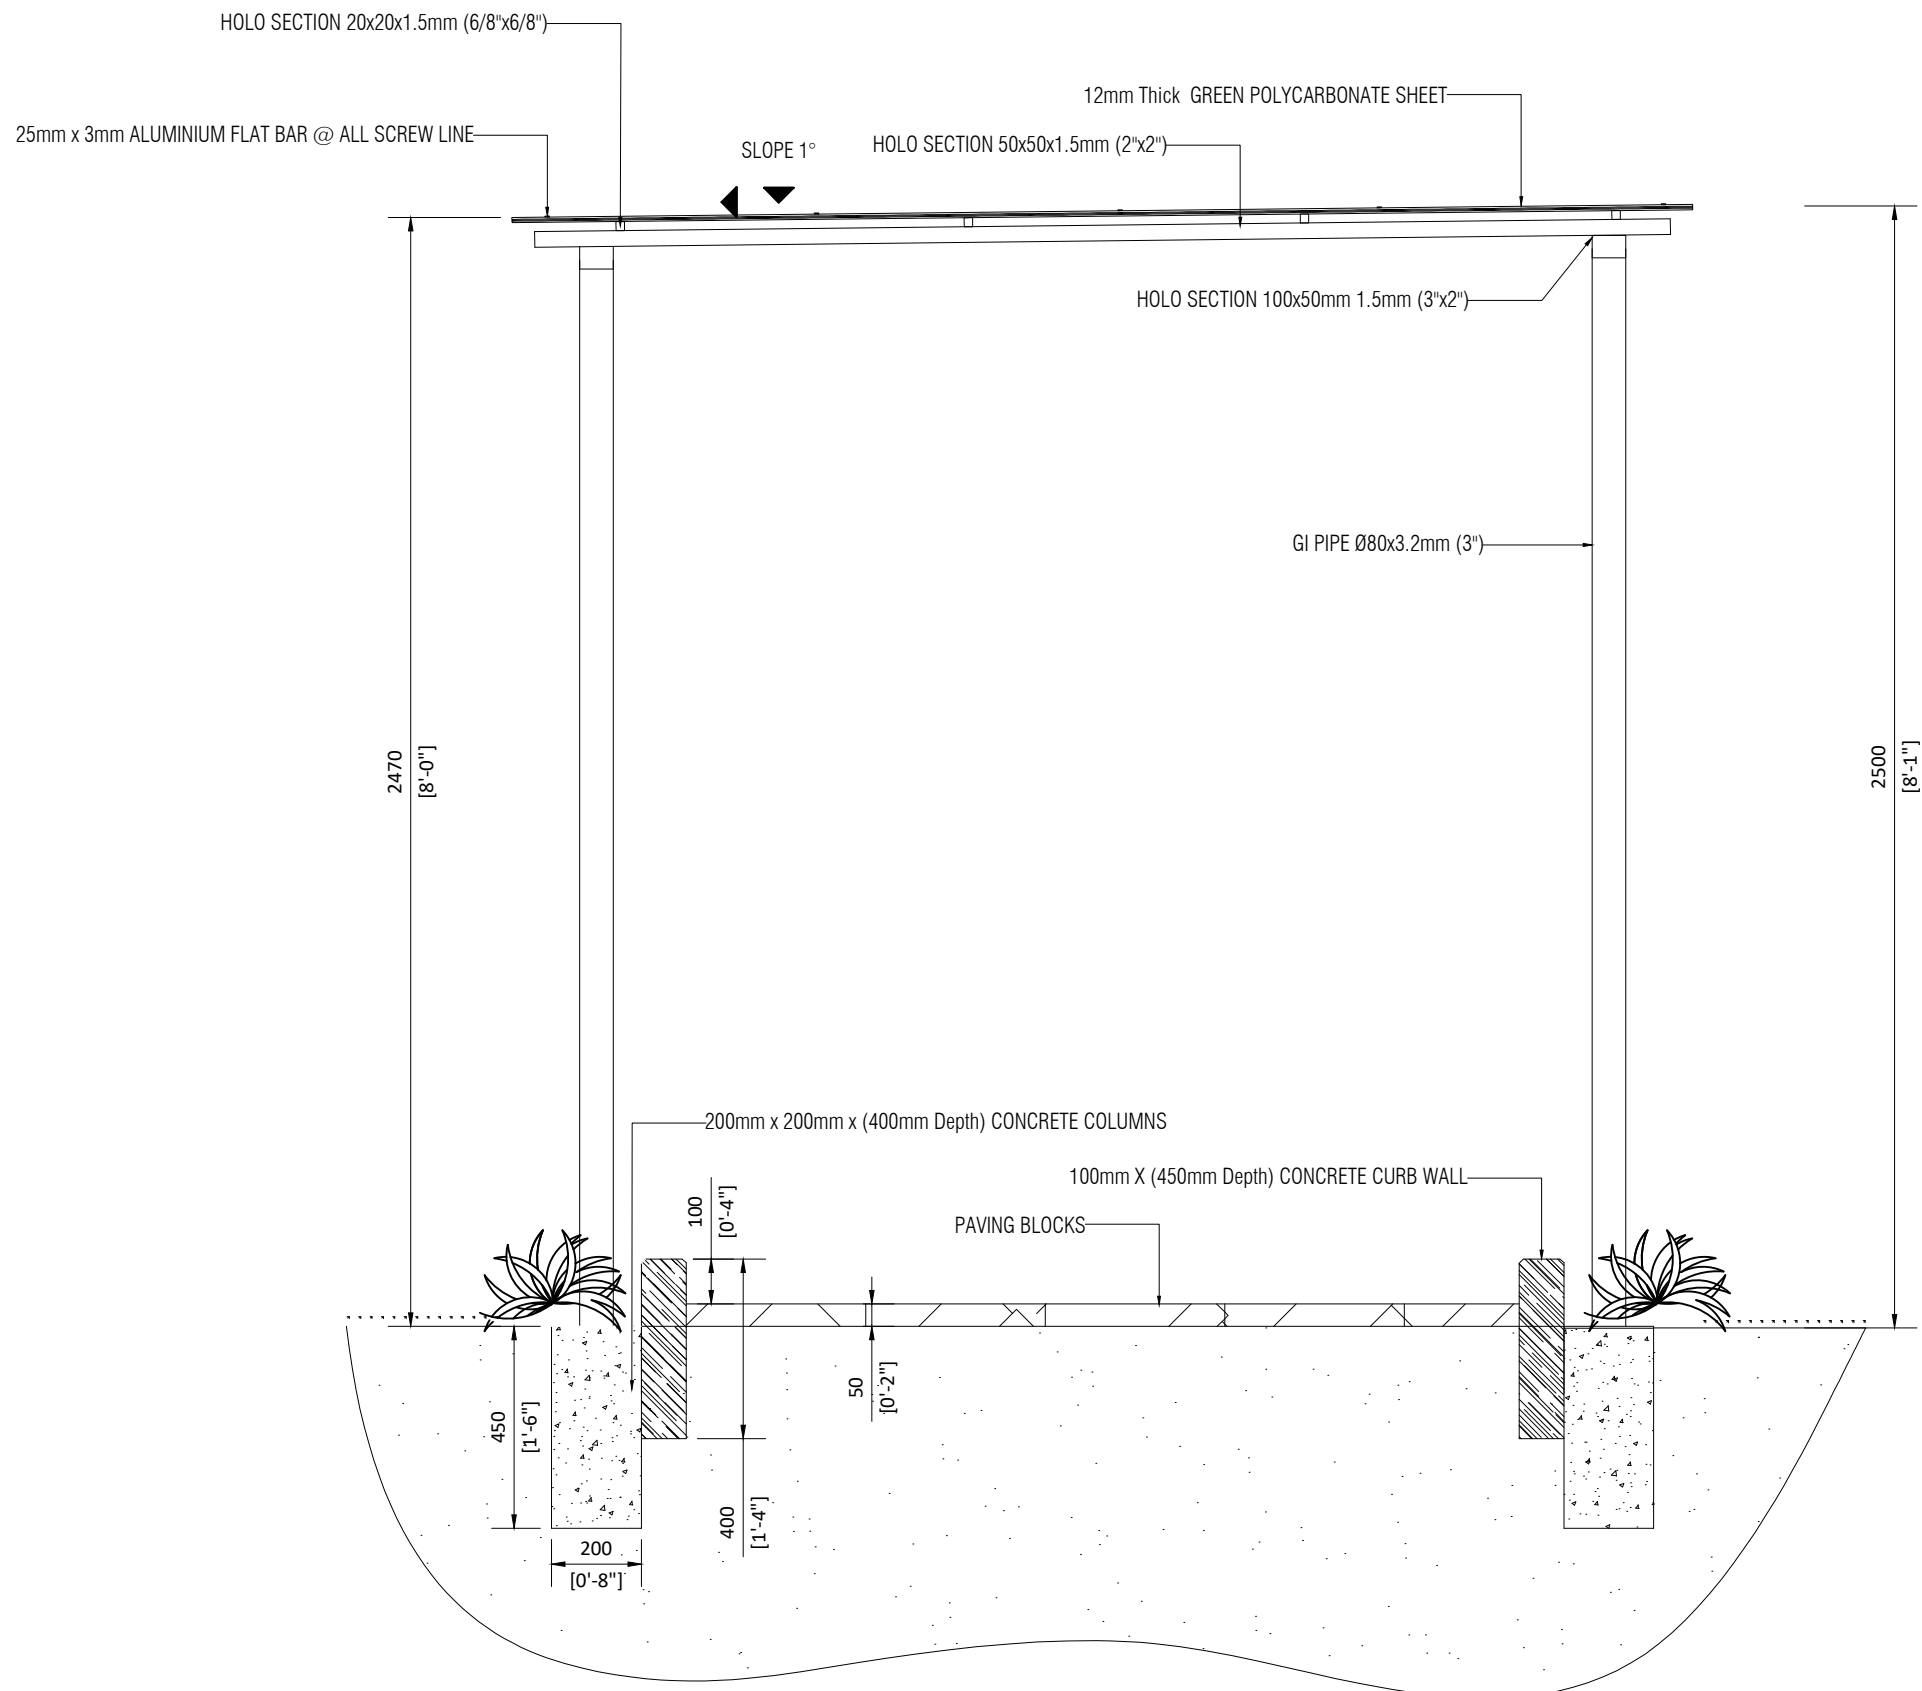

SECTION XX
1:20



Proposed Park Landscape

- PHASE:
- CONCEPT DESIGN
 - DESIGN DEVELOPMENT
 - TENDER DOCUMENT
 - FOR CONSTRUCTION
 - AS BUILD DRAWINGS


DESIGNATION	NAME
ARCHITECT	Nimreesh
CHECKED	Aruban
DRAWN	Nimreesh
CLIENT	ASMH

Amendment - 03 (08-04-2023)



NEEMRANA
Pvt Ltd


CODE	DATE	DWG. NO:
	11-03-2023	10
FORMAT	A1 A2 A3	ISSUE A
SCALE	- - -	
FILE NAME:		

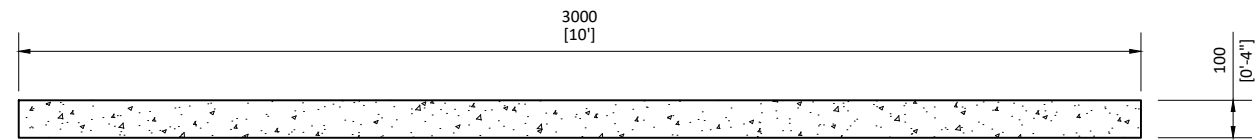


PLAN




CONCEPT TILES

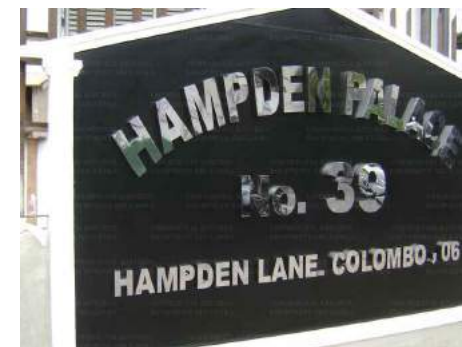

CONCEPT WALL

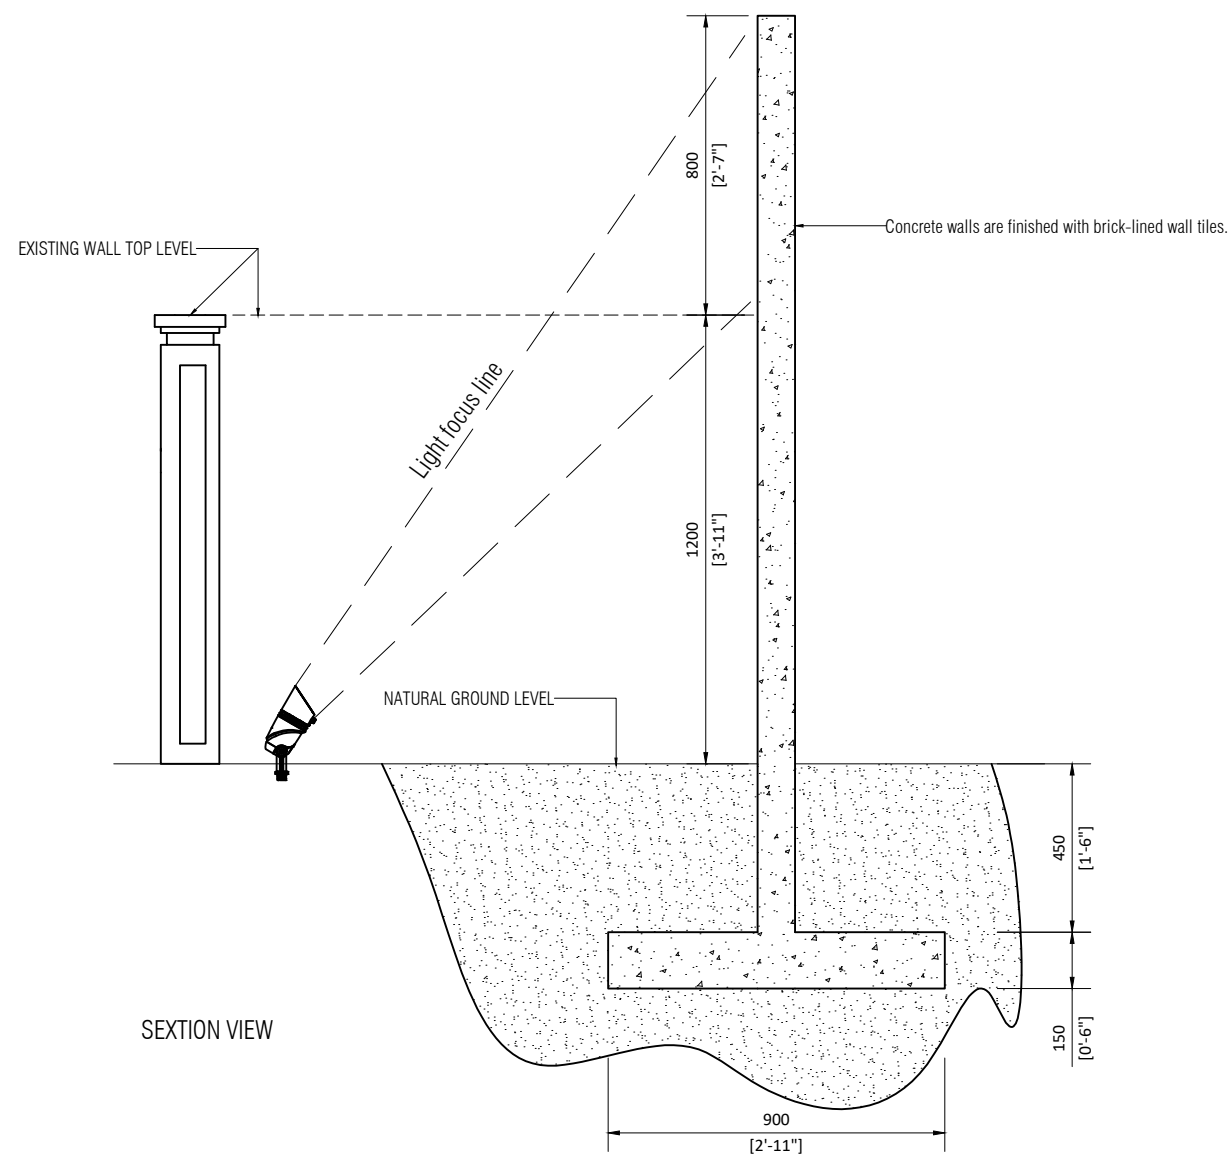

SECTION VIEW

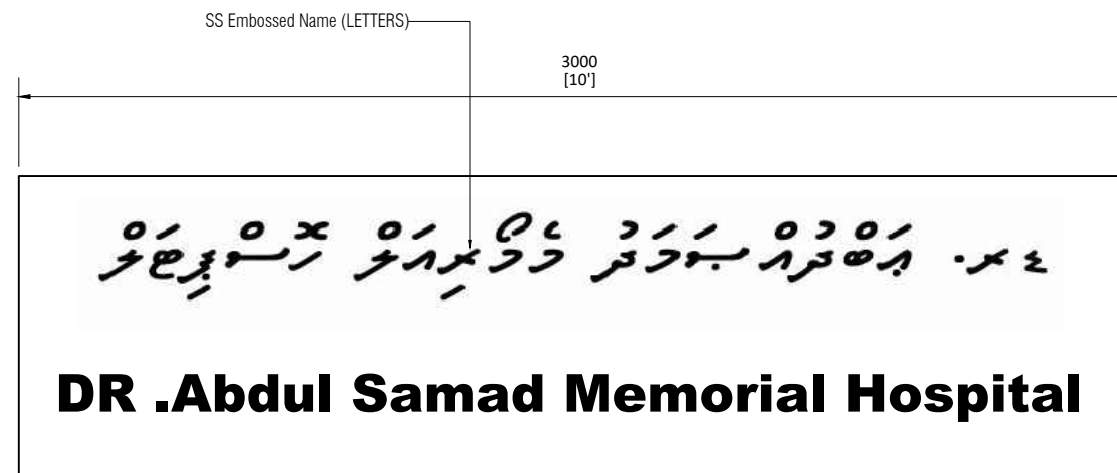

FRONT VIEW

SIGN BOARD STRUCTURAL AND DETAILS

1:20



Proposed Park Landscape


- PHASE:
- CONCEPT DESIGN
 - DESIGN DEVELOPMENT
 - TENDER DOCUMENT
 - FOR CONSTRUCTION
 - AS BUILD DRAWINGS

DESIGNATION	NAME
ARCHITECT	Nimrah
CHECKED	Aruban
DRAWN	Nimrah
CLIENT	ASMH


Amendment - 03 (08-04-2023)



CODE	DATE	DWG. NO:
11-03-2023		11
FORMAT	A1 A2 A3	ISSUE A
SCALE	- - -	
FILE NAME:		

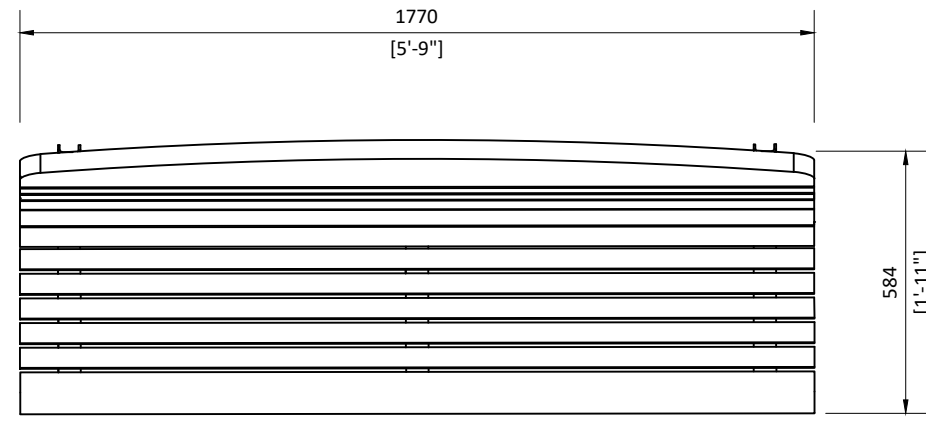

PLAN

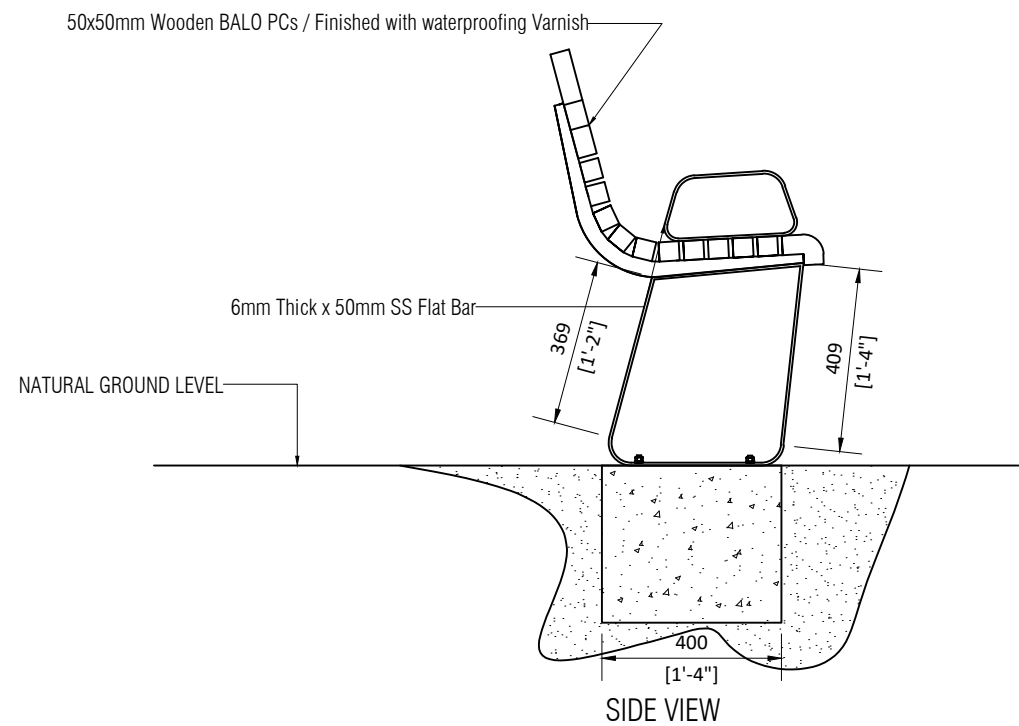

CONCEPT CHAIR

BENCH DETAILS
1:20

Proposed Park Landscape

- PHASE:
- CONCEPT DESIGN
 - DESIGN DEVELOPMENT
 - TENDER DOCUMENT
 - FOR CONSTRUCTION
 - AS BUILD DRAWINGS


DESIGNATION	NAME
ARCHITECT	Nimreesh
CHECKED	Aruban
DRAWN	Nimreesh
CLIENT	ASMH

Amendment - 03 (08-04-2023)




NEEMRANA
Pvt Ltd


CODE	DATE	DWG. NO:
	11-03-2023	12
FORMAT	A1 A2 A3	ISSUE A
SCALE	- - -	
FILE NAME:		

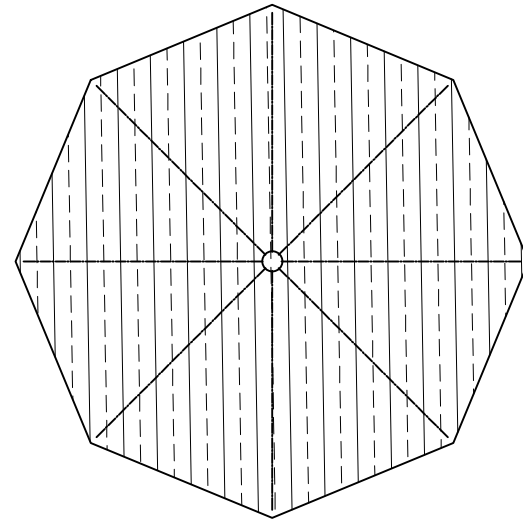


ROOF COVERING PLAN

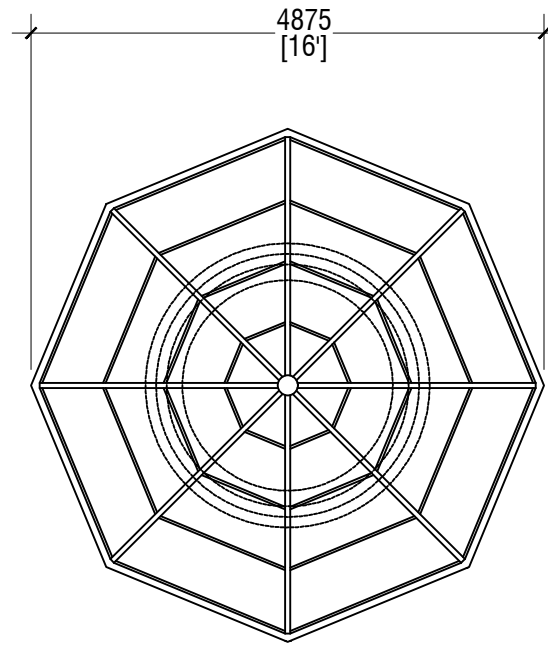

PLAN

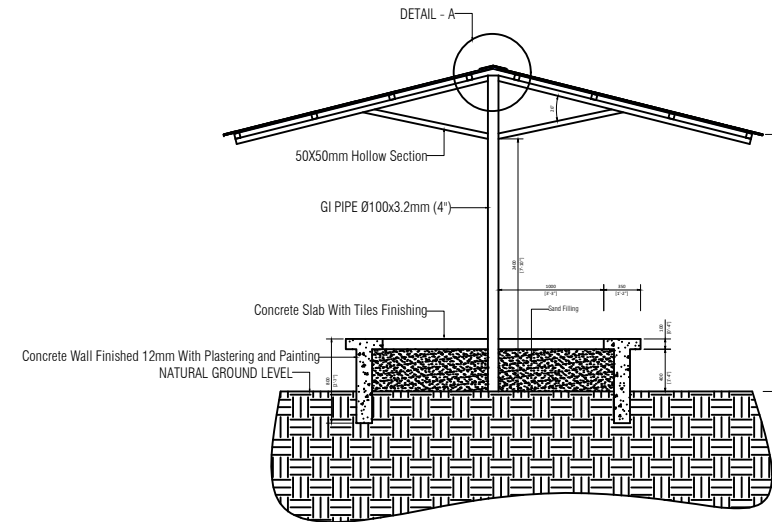

SECTION

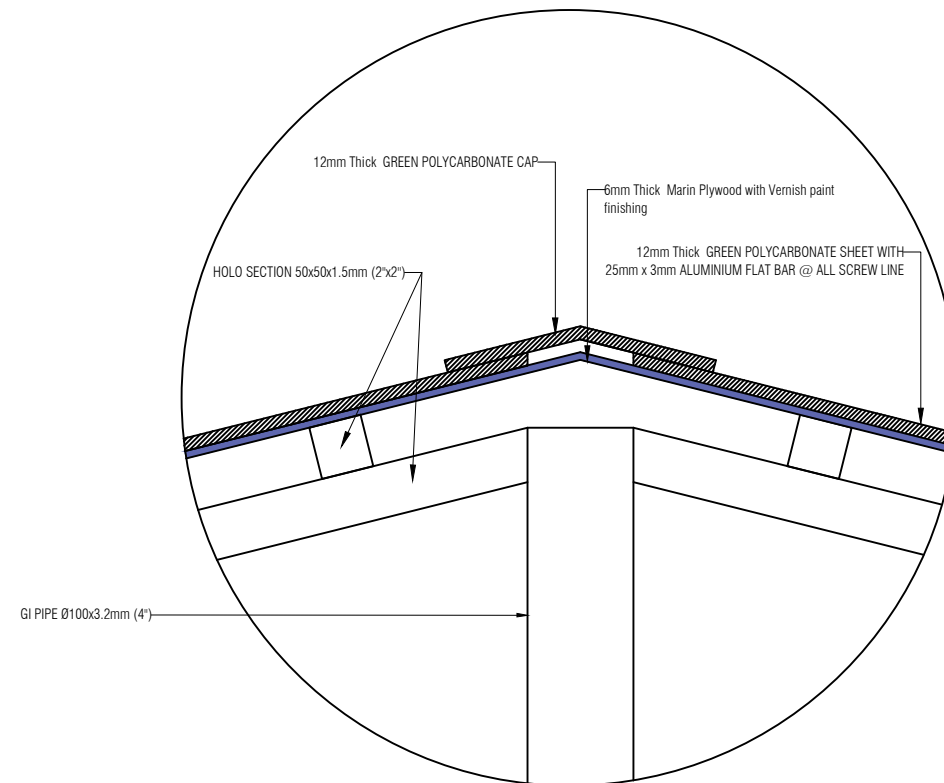

DETAIL - A

HUT DETAILS

1:20

Proposed Park Landscape

- PHASE:
- CONCEPT DESIGN
 - DESIGN DEVELOPMENT
 - TENDER DOCUMENT
 - FOR CONSTRUCTION
 - AS BUILD DRAWINGS


DESIGNATION	NAME
ARCHITECT	Nimreesh
CHECKED	Aruban
DRAWN	Nimreesh
CLIENT	ASMH

Amendment - 03 (08-04-2023)



NEEMRANA
Pvt Ltd

CODE	DATE	DWG. NO:
	11-03-2023	13
FORMAT	A1 A2 A3	ISSUE A
SCALE	- - -	
FILE NAME:		

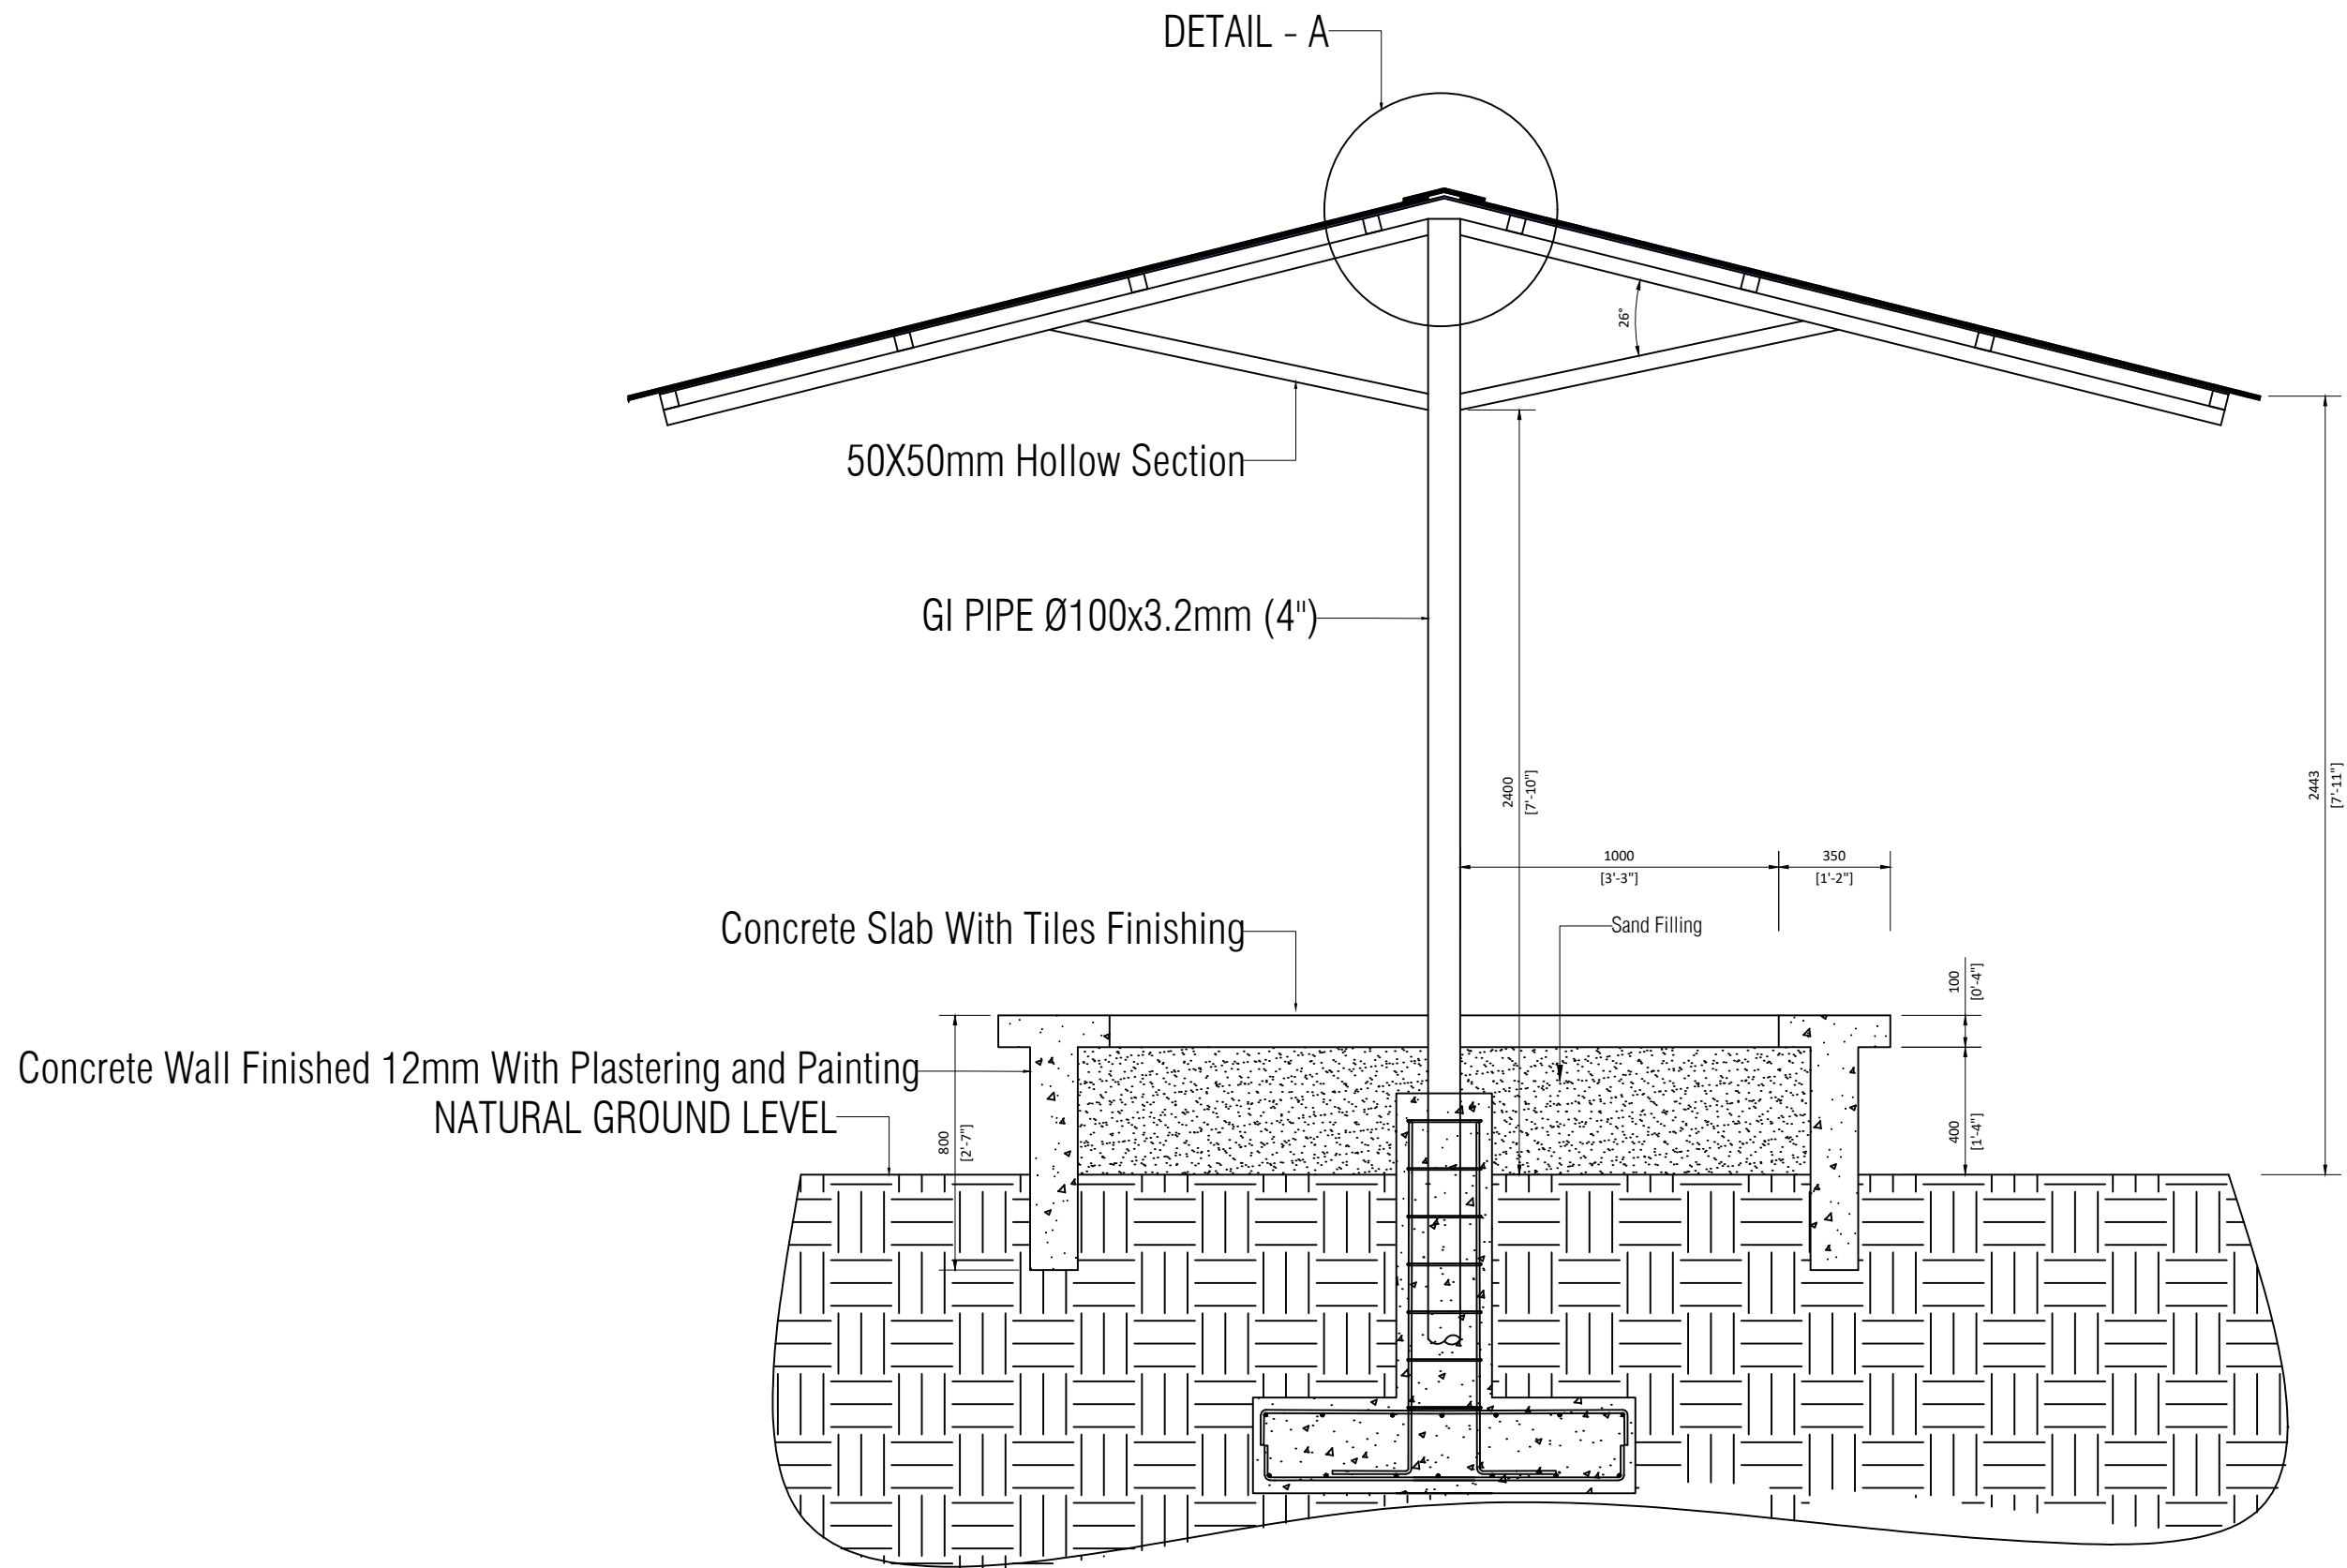

SECTION

Proposed Park Landscape

- PHASE:
- CONCEPT DESIGN
 - DESIGN DEVELOPMENT
 - TENDER DOCUMENT
 - FOR CONSTRUCTION
 - AS BUILD DRAWINGS

DESIGNATION	NAME
ARCHITECT	Nimish
CHECKED	Arjun
DRAWN	Nimish
CLIENT	ASMI

Amendment - 03 (08-04-2023)





NEEMRANA
Pvt. Ltd.

CODE	DATE	DWG. NO.
	11-03-2023	14
FORMAT	A1 A2 A3	ISSUE A
SCALE	-	-
FILE NAME:		

FOOTING DETAILS

TYPE	DIMENSION	REINFORCEMENT
F1	1200x1200x300	TOP AND BOTTOM RFMT: T10@150 c/c (Both Way)

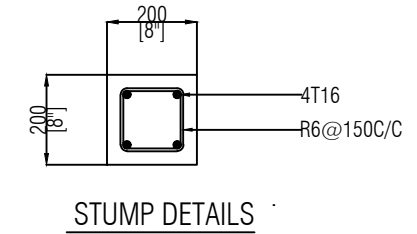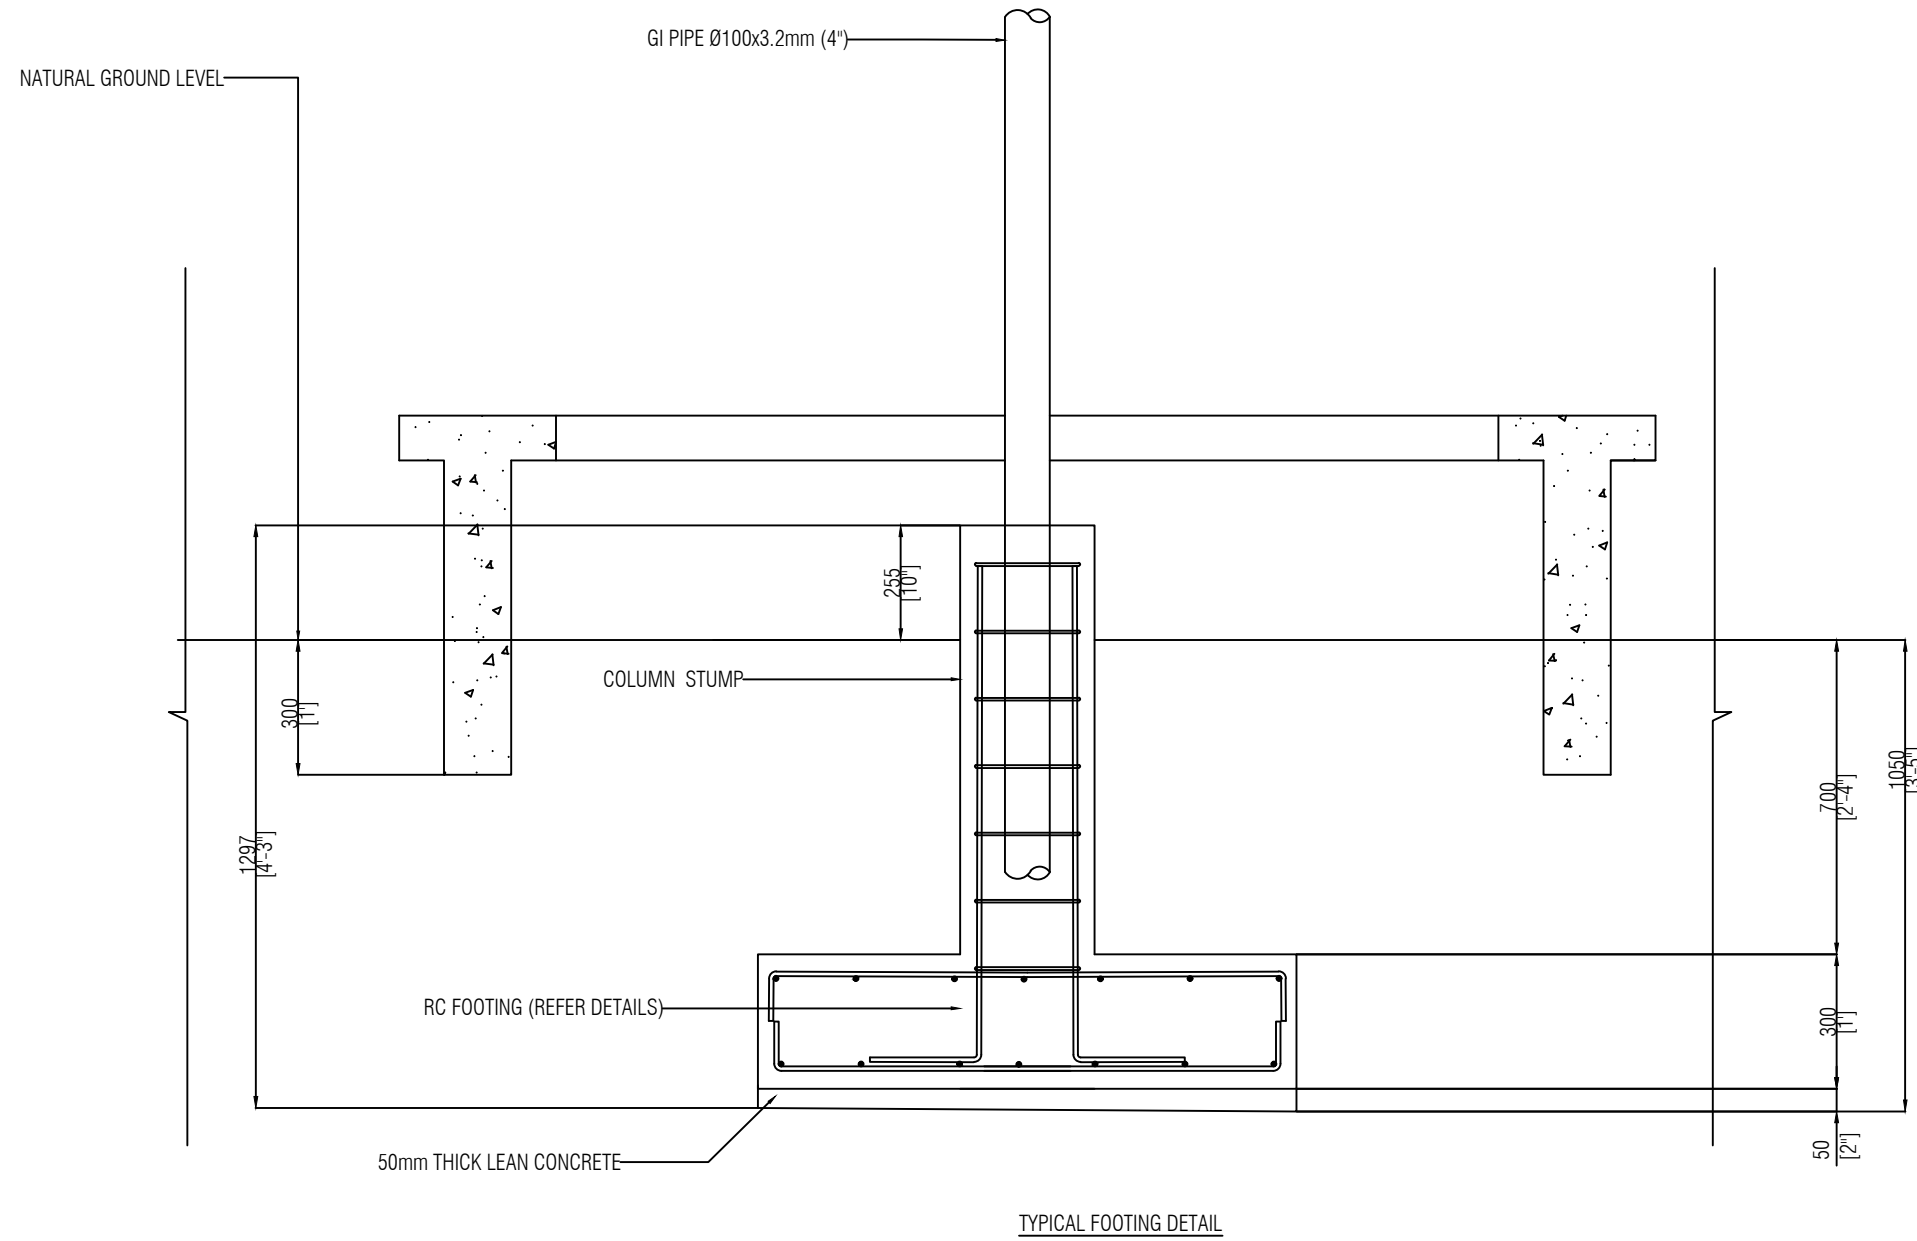

Proposed Park Landscape

- PHASE:
- CONCEPT DESIGN
 - DESIGN DEVELOPMENT
 - TENDER DOCUMENT
 - FOR CONSTRUCTION
 - AS BUILD DRAWINGS

DESIGNATION	NAME
ARCHITECT	Nimreesh
CHECKED	Aruban
DRAWN	Nimreesh
CLIENT	ASMH

Amendment - 03 (08-04-2023)



CODE		DATE	DWG. NO:
		11-03-2023	15
FORMAT	A1	A2	A3
SCALE	-	-	-
FILE NAME:			ISSUE A