


**PROPOSED AUTHENTIC MALDIVES OUTLET AT
AA. THODDOO**

INTERIOR DRAWINGS

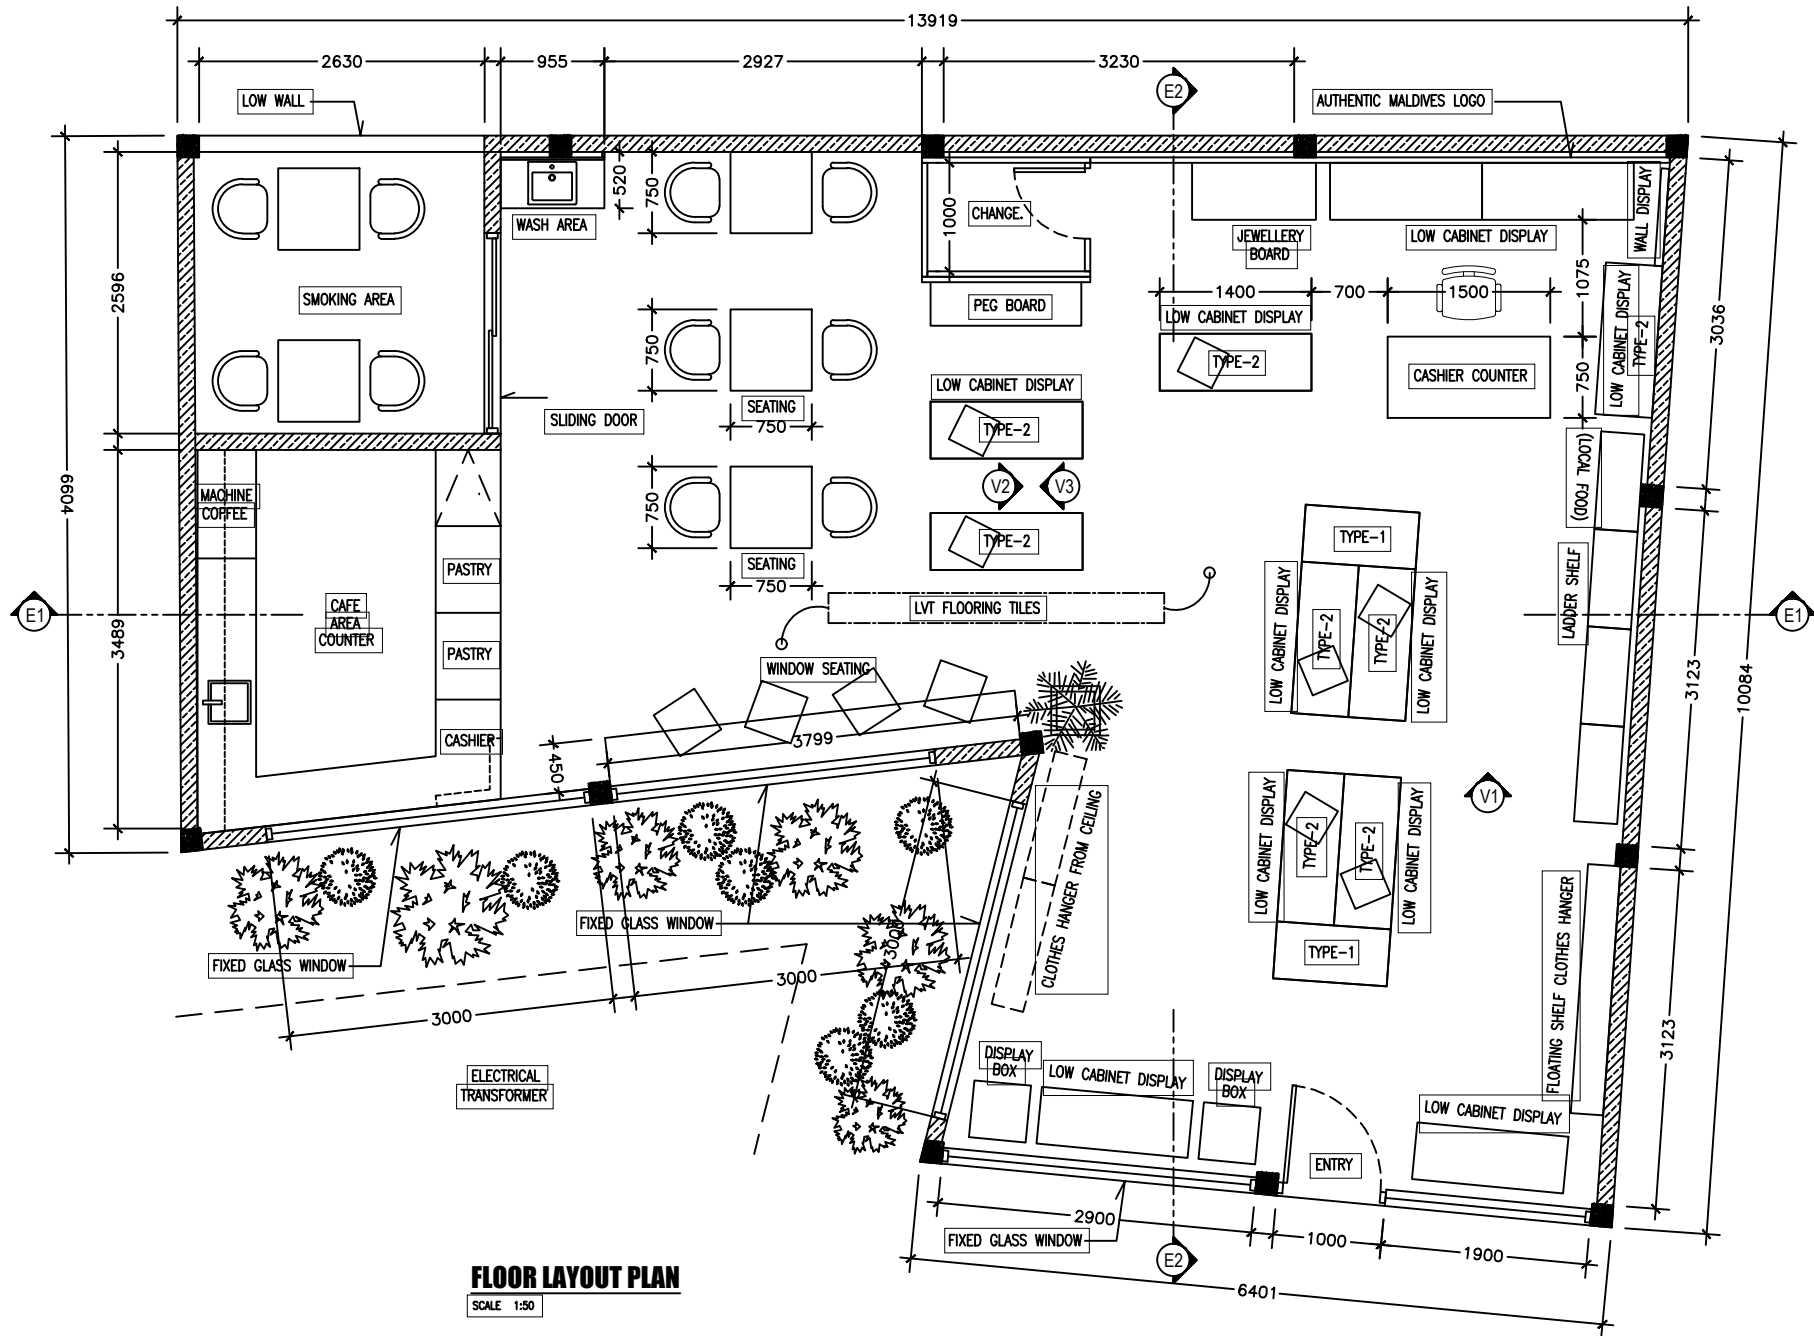

FLOOR LAYOUT PLAN

SCALE 1:50


CONTRACTORS MUST CHECK ALL DIMENSIONS ON SITE BEFORE STARTING ANY WORK OR SHOP DRAWINGS FIGURED DIMENSIONS TO TAKE PRECEDENCE OVER SCALE READINGS

REVISION:	ARCHITECT:	-
	ENGINEER:	-
	ARC. CHECKER:	-
	STR. CHECKER:	-
	DRAWN BY:	ASFAN AHMED

PROJECT:	PROPOSED AUTHENTIC MALDIVES OUTLET @ AA. THOODOO		
LOCATION:	AA. THOODOO, MALDIVES		
DRAWING TITLE:	AS GIVEN		
CLIENT:	-		
SCALE:	AS GIVEN	DIMENSION:	MM
		DATE:	MARCH 2023


A-01

DWG NO
PROJECT NO.: 23-000

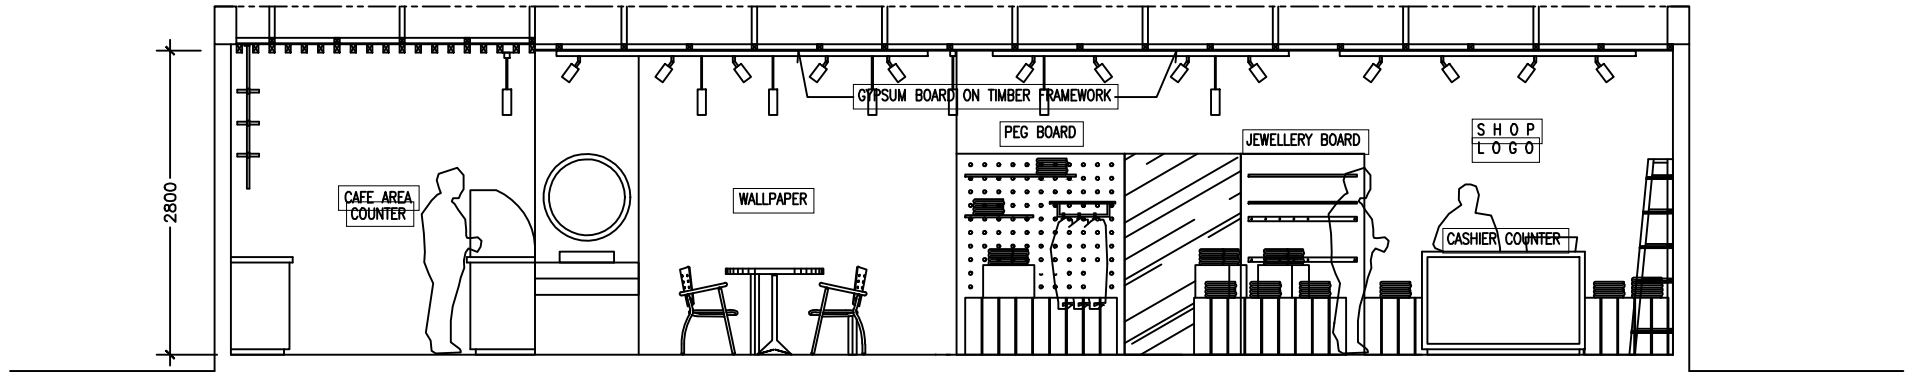

ELEVATION E1-E1

SCALE 1:50

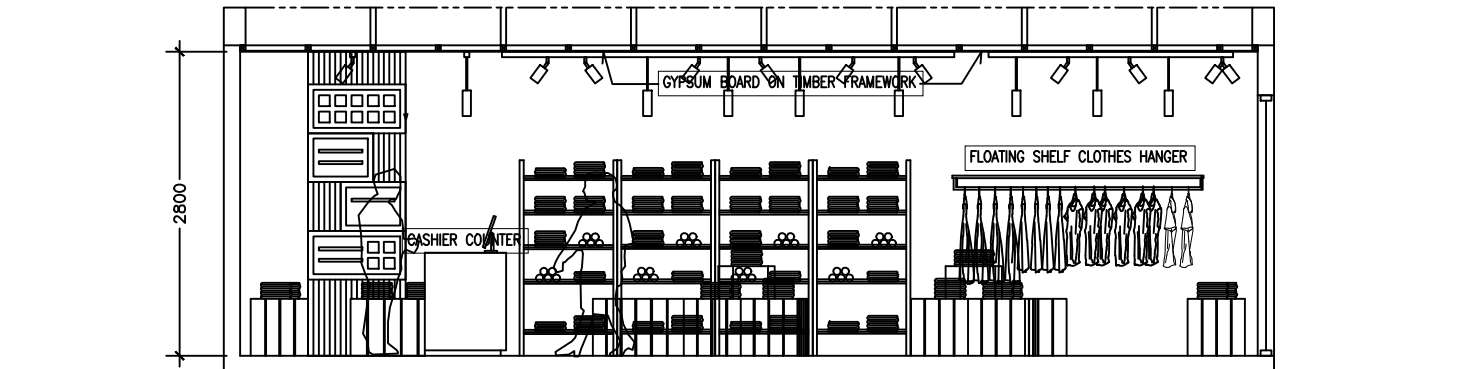

ELEVATION E2-E2

SCALE 1:50

CONTRACTORS MUST
CHECK ALL
DIMENSIONS ON SITE
BEFORE STARTING
ANY WORK OR SHOP
DRAWINGS. FIGURED
DIMENSIONS TO TAKE
PRECEDENCE OVER
SCALE READINGS

REVISION:

ARCHITECT:


-
ENGINEER:
ARC. CHECKER:
STR. CHECKER:
DRAWN BY: ASFAN AHMED

PROJECT:

PROPOSED AUTHENTIC MALDIVES OUTLET @ AA. THOODOO
LOCATION: AA. THOODOO, MALDIVES
DRAWING TITLE: AS GIVEN
CLIENT: -
SCALE: AS GIVEN
DIMENSION: MM

A-02

DWG NO
PROJECT NO.: 23-000

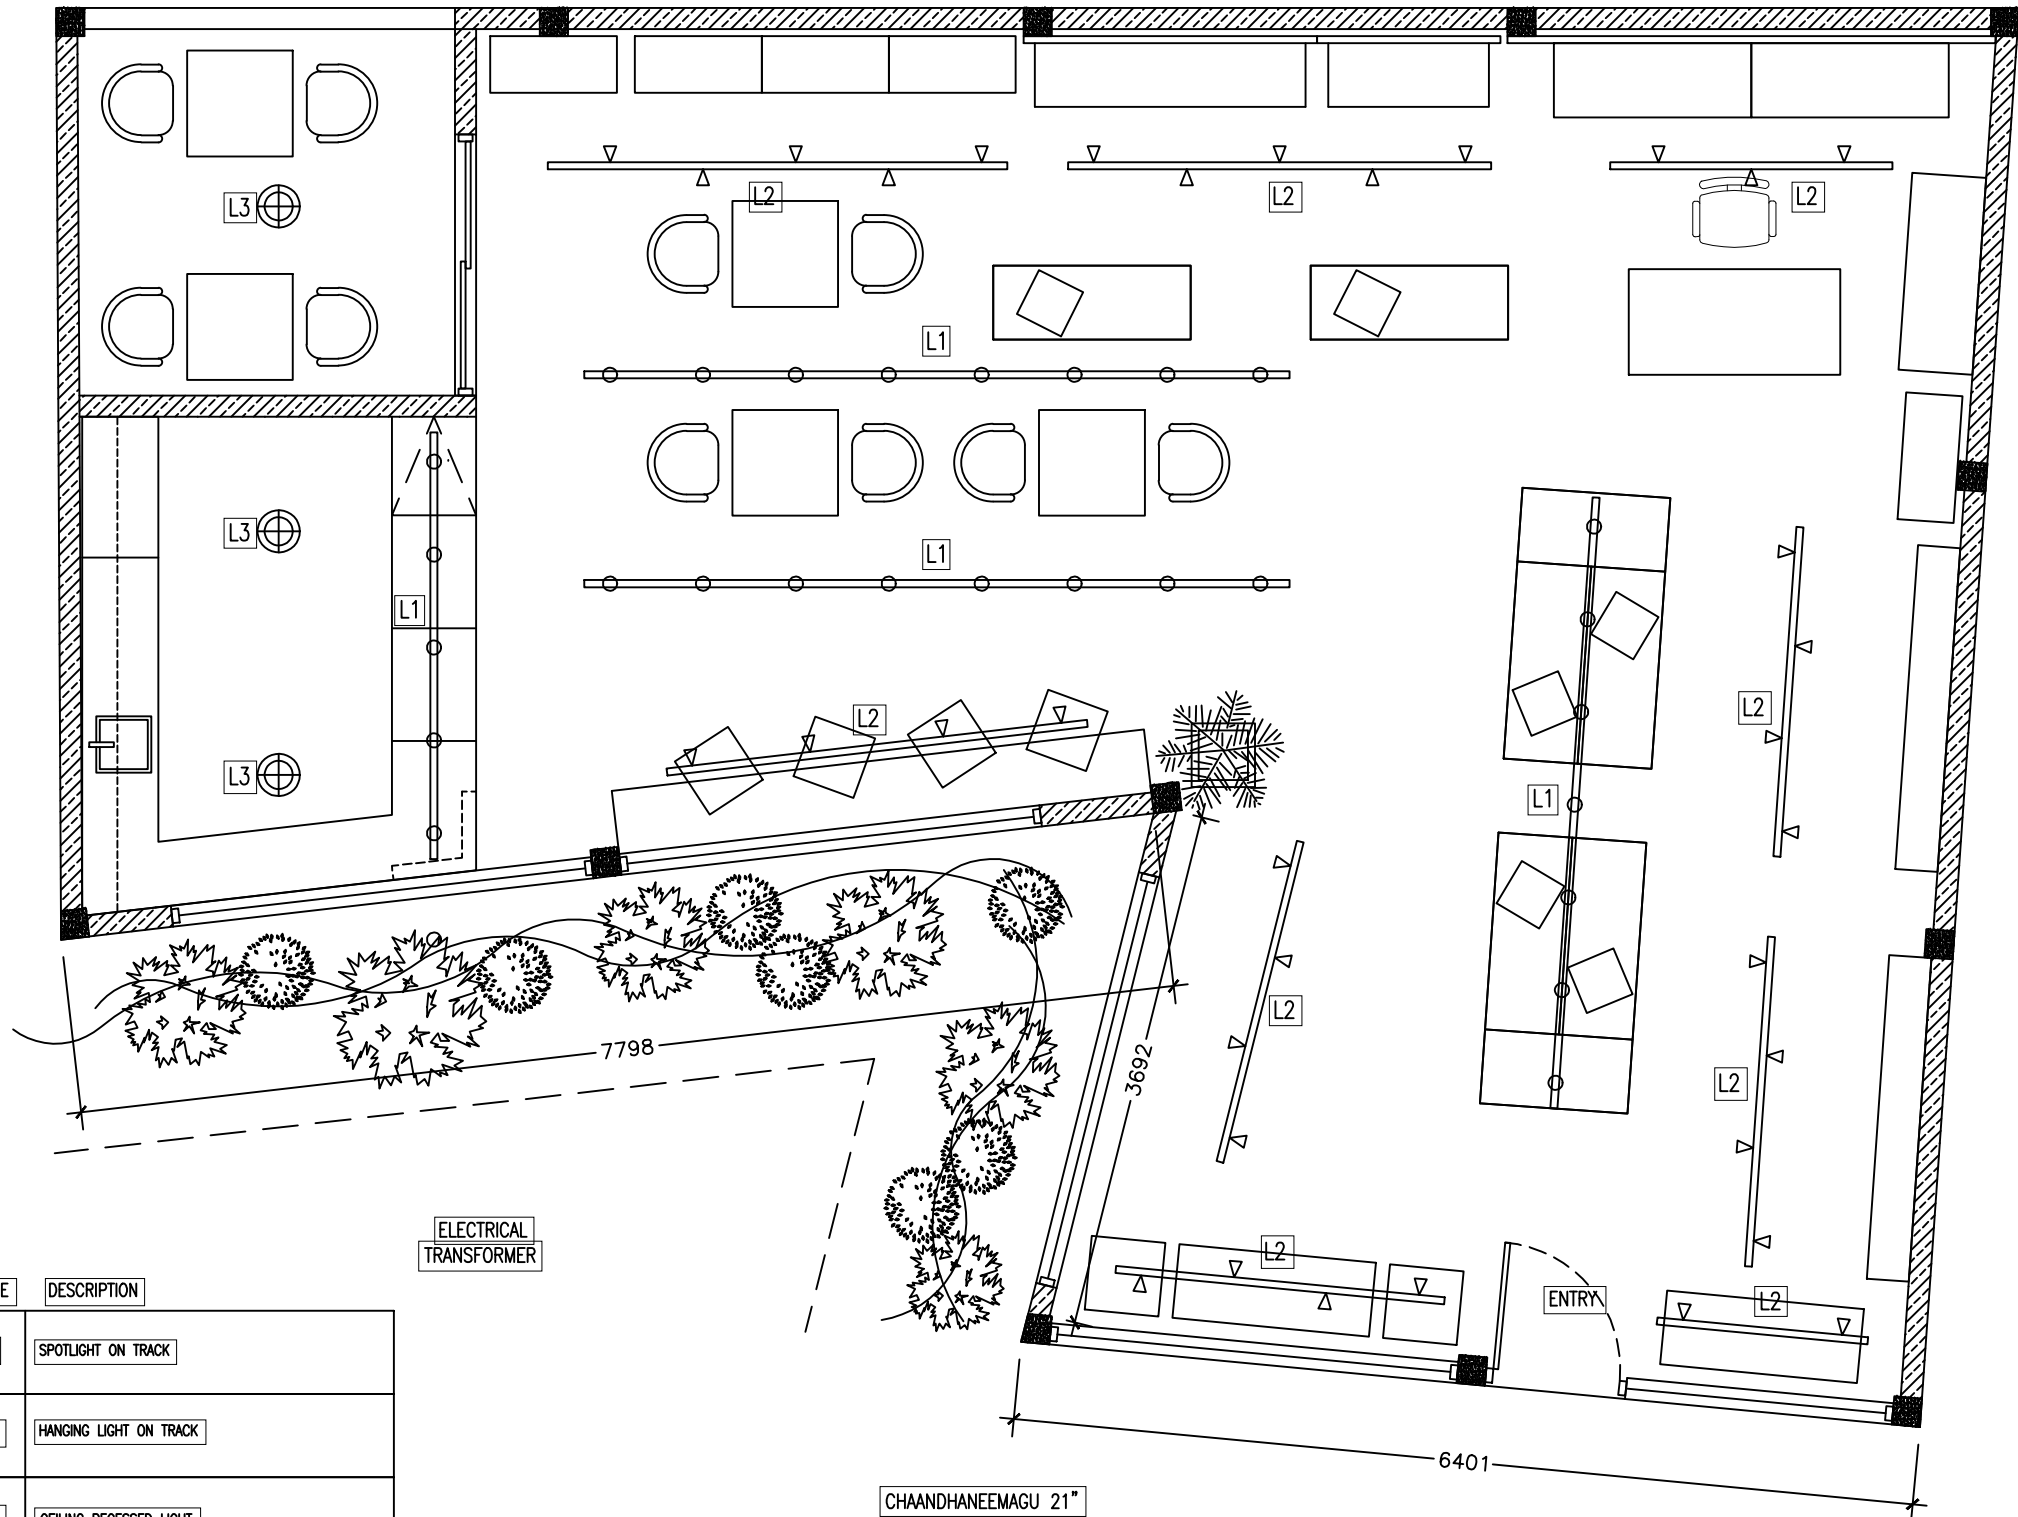

SYMBOL	CODE	DESCRIPTION
	L1	SPOTLIGHT ON TRACK
	L2	HANGING LIGHT ON TRACK
	L3	CEILING RECESSED LIGHT

ELECTRICAL TRANSFORMER

LIGHTING LAYOUT PLAN


SCALE 1:50

CONTRACTORS MUST CHECK ALL DIMENSIONS ON SITE BEFORE STARTING ANY WORK OR SHOP DRAWINGS. FIGURED DIMENSIONS TO TAKE PRECEDENCE OVER SCALE READINGS

REVISION:	ARCHITECT:	-
	ENGINEER:	-
	ARC. CHECKER:	-
	STR. CHECKER:	-
	DRAWN BY:	ASFAN AHMED

PROJECT:	PROPOSED AUTHENTIC MALDIVES OUTLET @ AA. THODDOO
LOCATION:	AA. THODDOO, MALDIVES
DRAWING TITLE:	AS GIVEN
CLIENT:	-
SCALE:	AS GIVEN
DIMENSION:	MM
DATE:	MARCH 2023

DWG NO	E-01
PROJECT NO.:	23-000

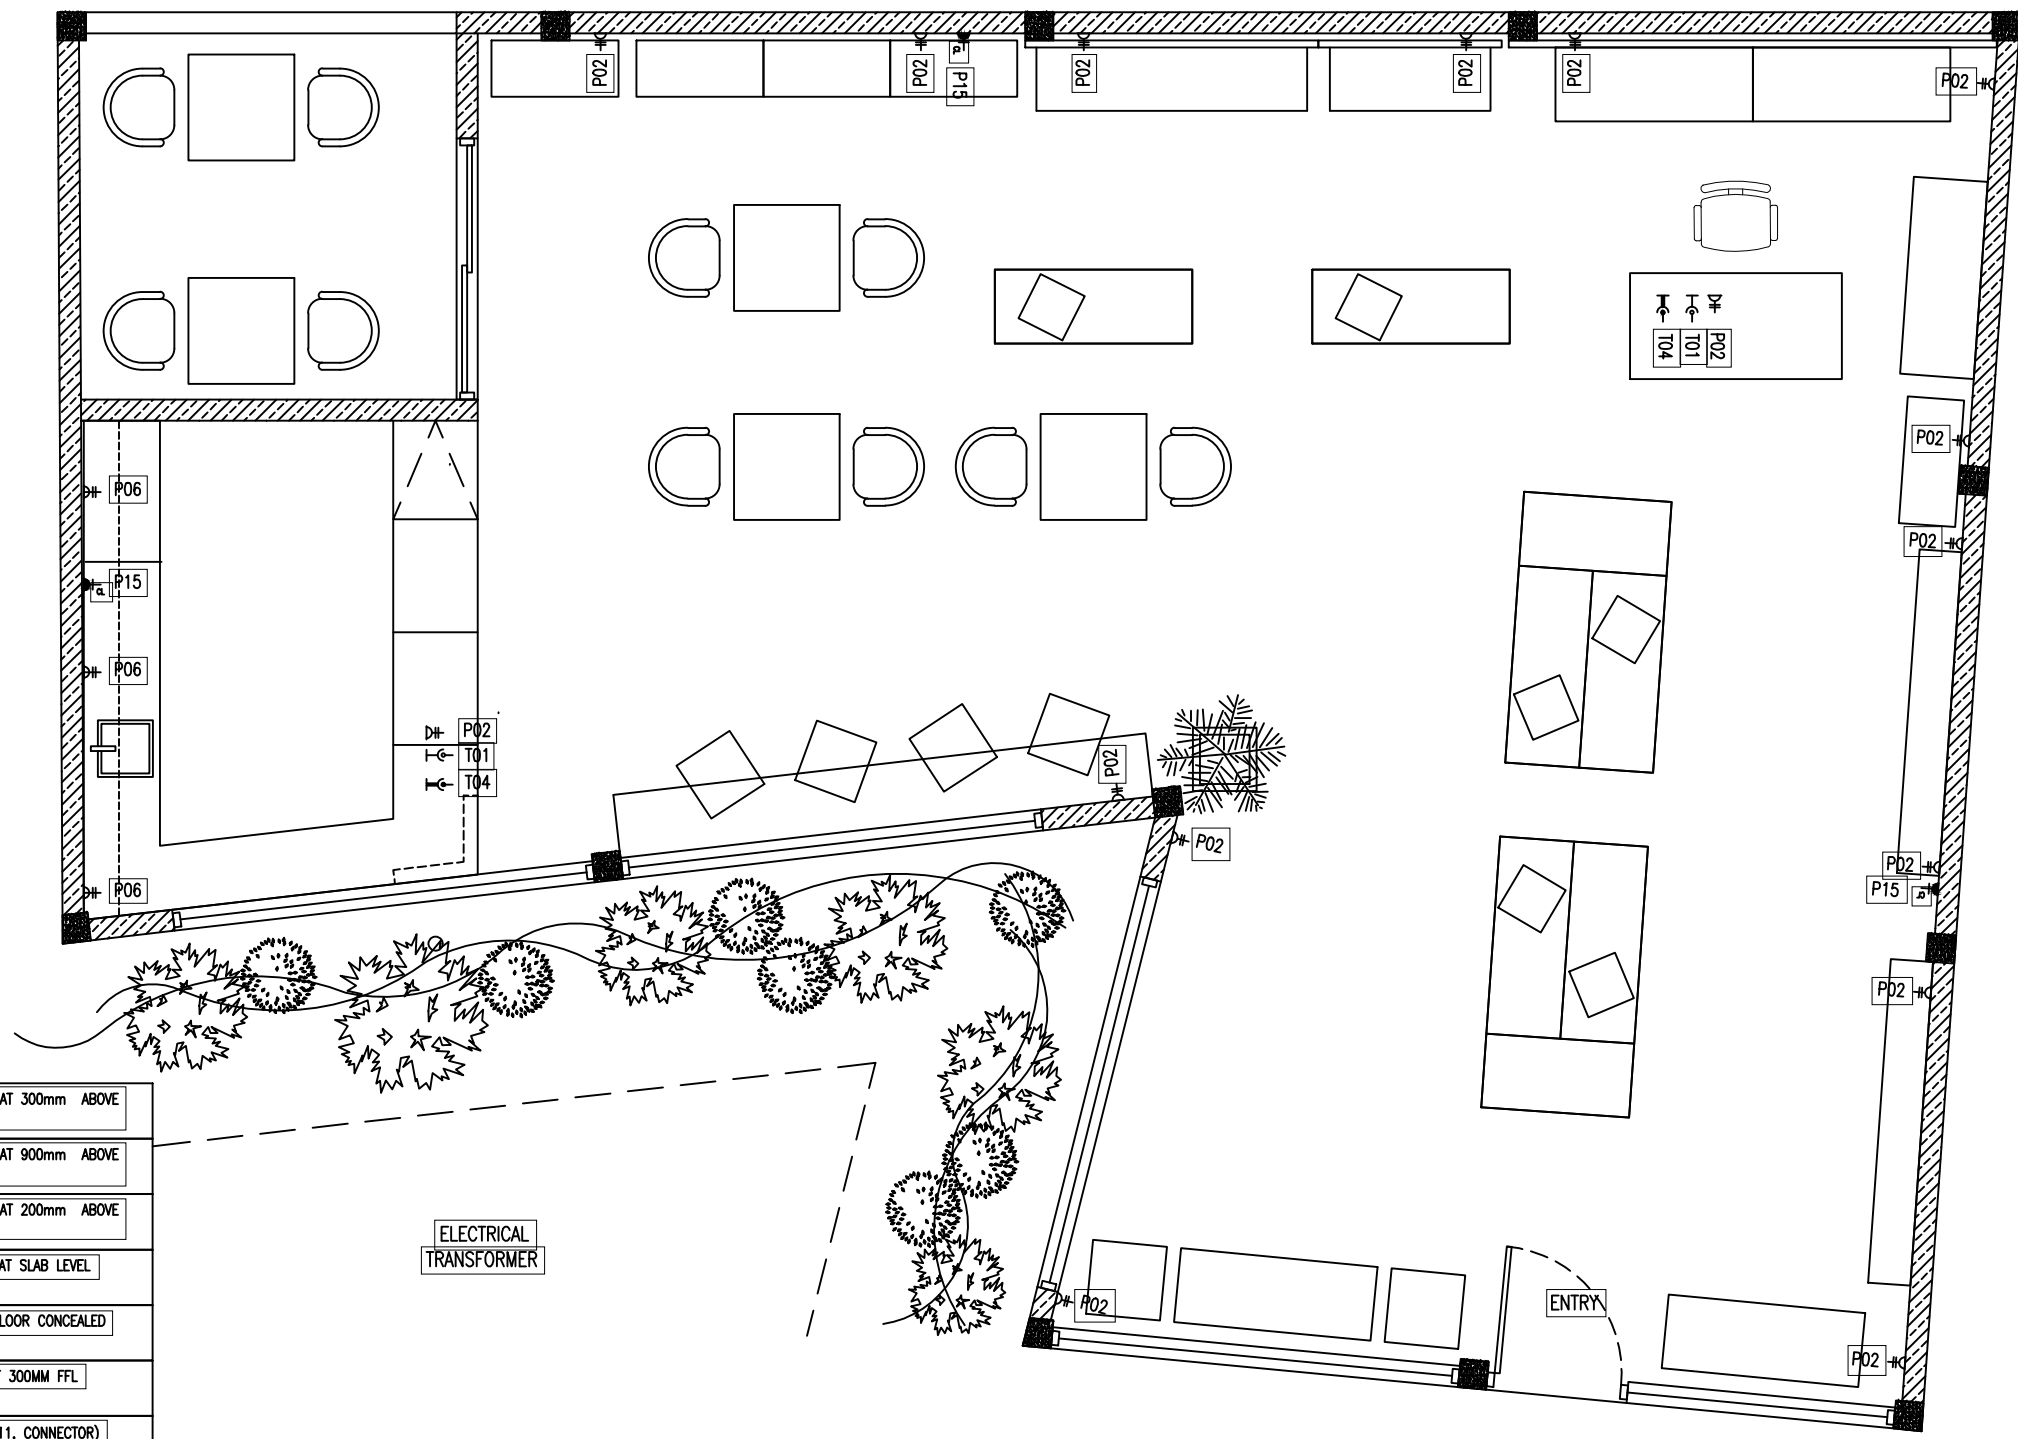

SYMBOL	CODE	DESCRIPTION
D#	P02	2 GANG13A SOCKET OUTLET AT 300mm ABOVE FINISHED FLOOR LEVEL
D#	P06	2 GANG13A SOCKET OUTLET AT 900mm ABOVE FINISHED FLOOR LEVEL
D#	P11	2 GANG13A SOCKET OUTLET AT 200mm ABOVE FINISHED FLOOR LEVEL
D#	P15	1 GANG13A SOCKET OUTLET AT SLAB LEVEL
D#	P13	2 GANG13A SOCKET OUTLET FLOOR CONCEALED
D#	P22	WATER PROOF 13A SOCKET AT 300MM FFL
T	T01	PLAIN TELEPHONE OUTLET (RJ11, CONNECTOR)
T	T04	COMPUTER NETWORK OUTLET (RJ 45 CONNECTORS)
T	T10	T.V POINT

ELECTRICAL SOCKET LAYOUT PLAN


SCALE 1:50

CONTRACTORS MUST CHECK ALL DIMENSIONS ON SITE BEFORE STARTING ANY WORK OR SHOP DRAWINGS. FIGURED DIMENSIONS TO TAKE PRECEDENCE OVER SCALE READINGS

REVISION:	ARCHITECT:	-
	ENGINEER:	-
	ARC. CHECKER:	-
	STR. CHECKER:	-
	DRAWN BY:	ASFAN AHMED

PROJECT:	PROPOSED AUTHENTIC MALDIVES OUTLET @ AA. THODDOO
LOCATION:	AA. THODDOO, MALDIVES
DRAWING TITLE:	AS GIVEN
CLIENT:	-
SCALE:	AS GIVEN
DIMENSION:	MM
DATE:	MARCH 2023

E-02
DWG NO
PROJECT NO.: 23-000

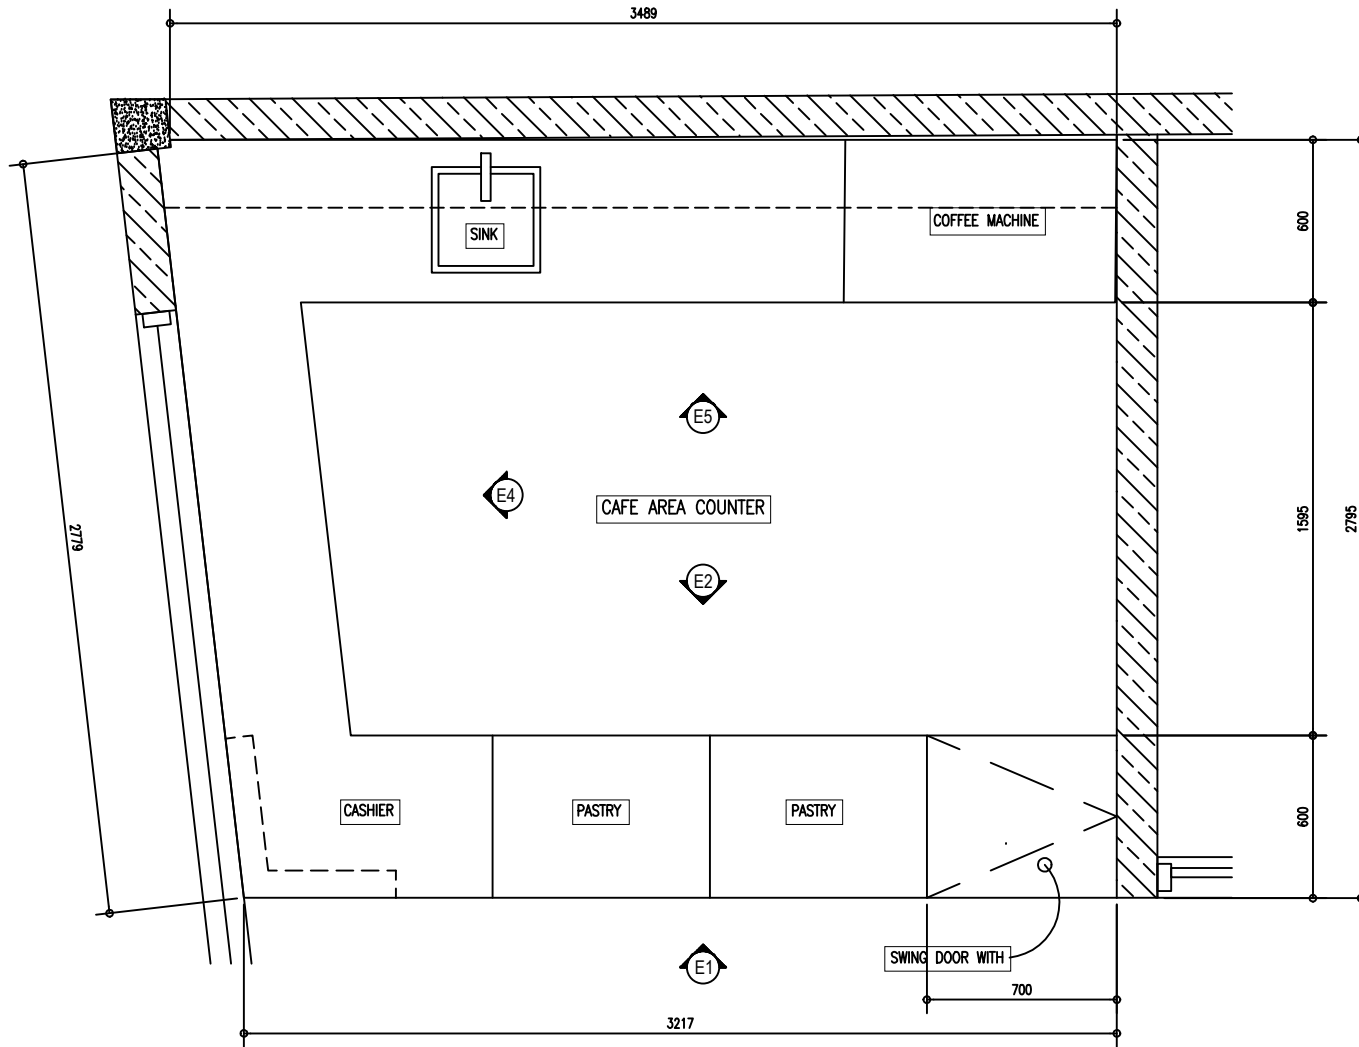


CAFE' COUNTER DETAILS - PLAN

SCALE 1:20

CONTRACTORS MUST CHECK ALL DIMENSIONS ON SITE BEFORE STARTING ANY WORK OR SHOP DRAWINGS. FIGURED DIMENSIONS TO TAKE PRECEDENCE OVER SCALE READINGS.

REVISION:	ARCHITECT: -	PROJECT: PROPOSED AUTHENTIC MALDIVES OUTLET @ AA. THODDOO	ID-07
	ENGINEER: -	LOCATION: AA. THODDOO, MALDIVES	
	ARC. CHECKER: -	DRAWING TITLE: AS GIVEN	
	STR. CHECKER: -	CLIENT: -	
	DRAWN BY: ASFAN AHMED	SCALE: AS GIVEN DIMENSION: MM DATE: MARCH 2023	
			DWG NO
			PROJECT NO.: 23-000

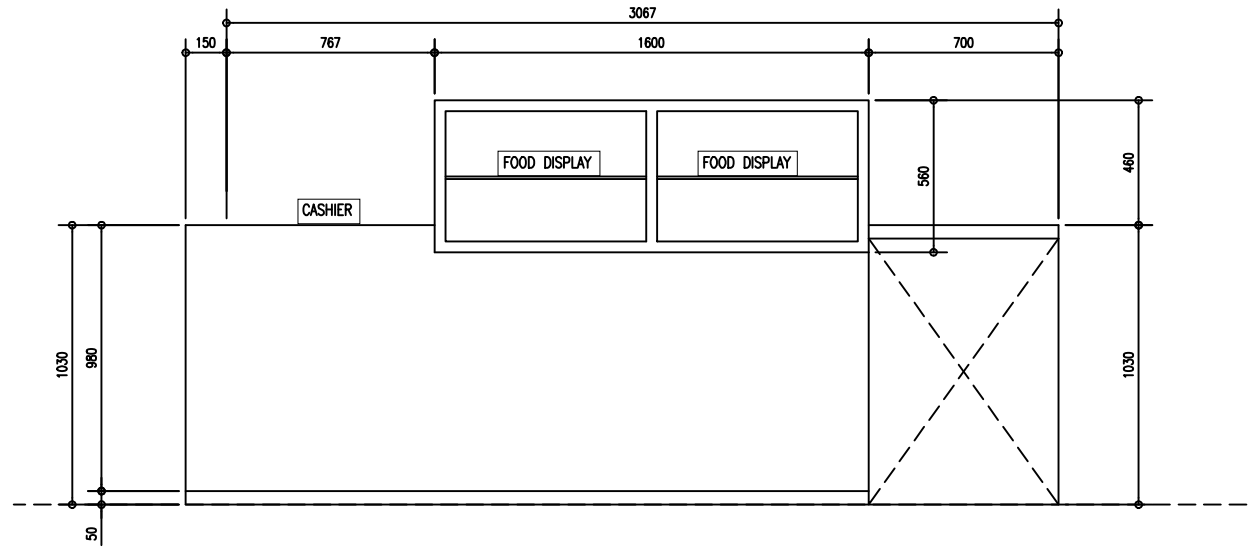

ELEVATION - E1 - COUNTER

SCALE 1:20

CONTRACTORS MUST
CHECK ALL
DIMENSIONS ON SITE
BEFORE STARTING
ANY WORK OR SHOP
DRAWINGS FIGURED
DIMENSIONS TO TAKE
PRECEDENCE OVER
SCALE READINGS

REVISION:

ARCHITECT:

-
-
-
-
ASFAN AHMED


PROJECT:

PROPOSED AUTHENTIC MALDIVES OUTLET @ AA. THODDOO
AA. THODDOO, MALDIVES
AS GIVEN
-
AS GIVEN
MM
MARCH 2023

ID-08

DWG NO

PROJECT NO.: 23-000

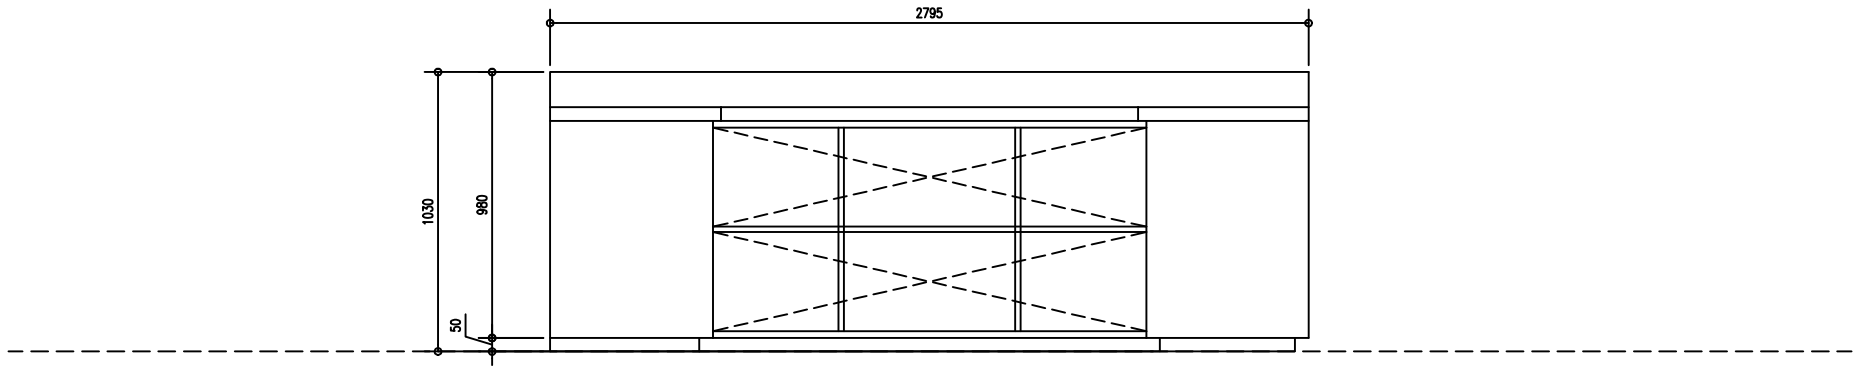

ELEVATION - E4 - COUNTER

SCALE 1:20

CONTRACTORS MUST
CHECK ALL
DIMENSIONS ON SITE
BEFORE STARTING
ANY WORK OR SHOP
DRAWINGS FIGURED
DIMENSIONS TO TAKE
PRECEDENCE OVER
SCALE READINGS

REVISION:

ARCHITECT:

-
ENGINEER: -
ARC. CHECKER: -
STR. CHECKER: -
DRAWN BY: ASFAN AHMED


PROJECT:

PROPOSED AUTHENTIC MALDIVES OUTLET @ AA. THODDODU
LOCATION: AA. THODDODU, MALDIVES
DRAWING TITLE: AS GIVEN
CLIENT: -
SCALE: AS GIVEN
DIMENSION: MM
DATE: MARCH 2023

ID-09

DWG NO

PROJECT NO.: 23-000

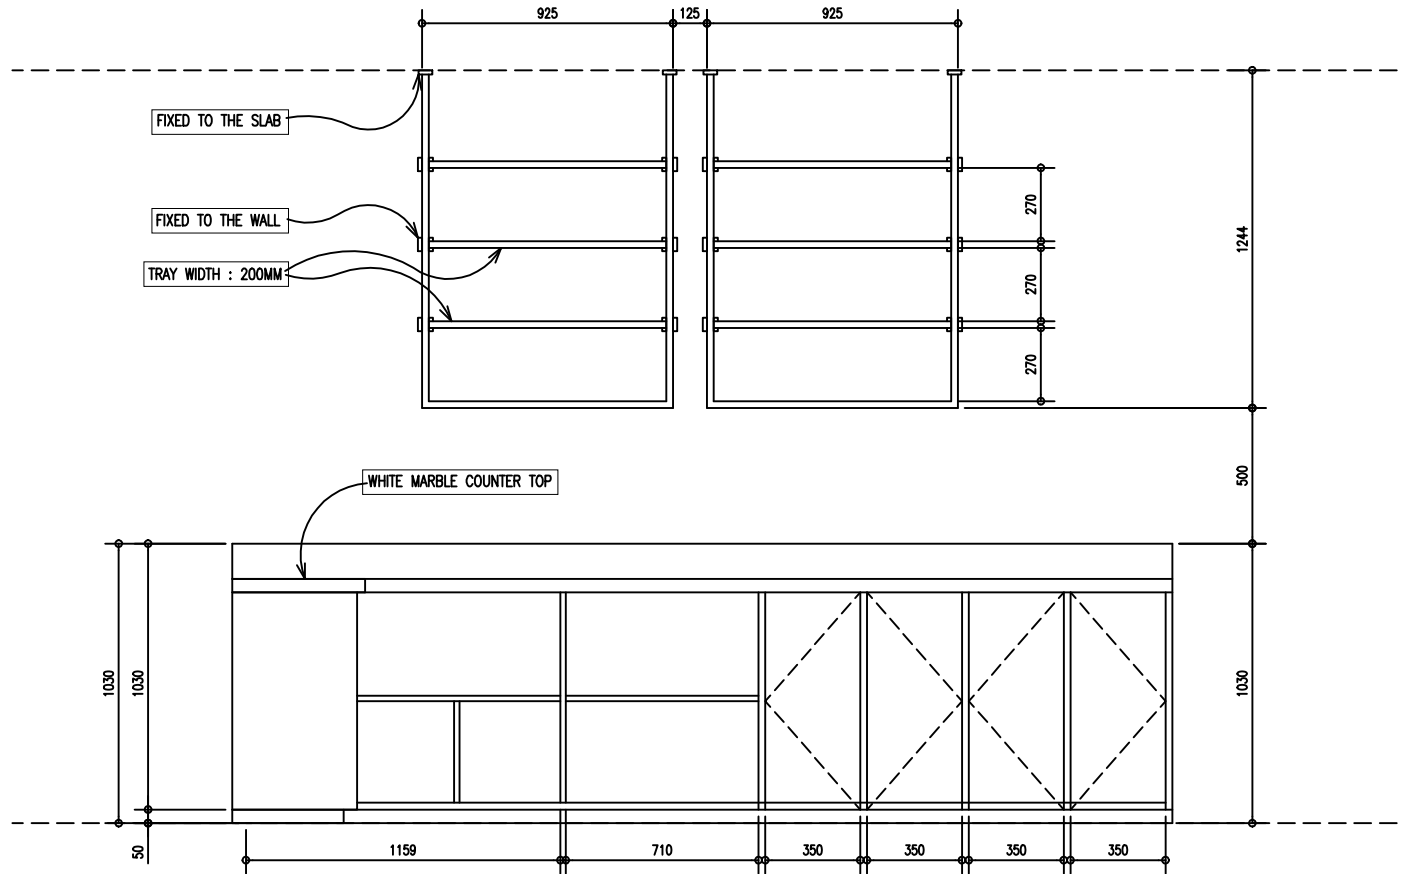

ELEVATION - E5 - COUNTER


SCALE 1:20

CONTRACTORS MUST CHECK ALL DIMENSIONS ON SITE BEFORE STARTING ANY WORK OR SHOP DRAWINGS. FIGURED DIMENSIONS TO TAKE PRECEDENCE OVER SCALE READINGS

REVISION:	ARCHITECT:	-
	ENGINEER:	-
	ARC. CHECKER:	-
	STR. CHECKER:	-
	DRAWN BY:	ASFAN AHMED



PROJECT:	PROPOSED AUTHENTIC MALDIVES OUTLET @ AA. THODDOO		
LOCATION:	AA. THODDOO, MALDIVES		
DRAWING TITLE:	AS GIVEN		
CLIENT:	-		
SCALE:	AS GIVEN	DIMENSION:	MM
DATE:	MARCH 2023		

ID-10	DWG NO
	PROJECT NO.: 23-00

 

PLAN - WALL DISPLAY

SCALE 1:20

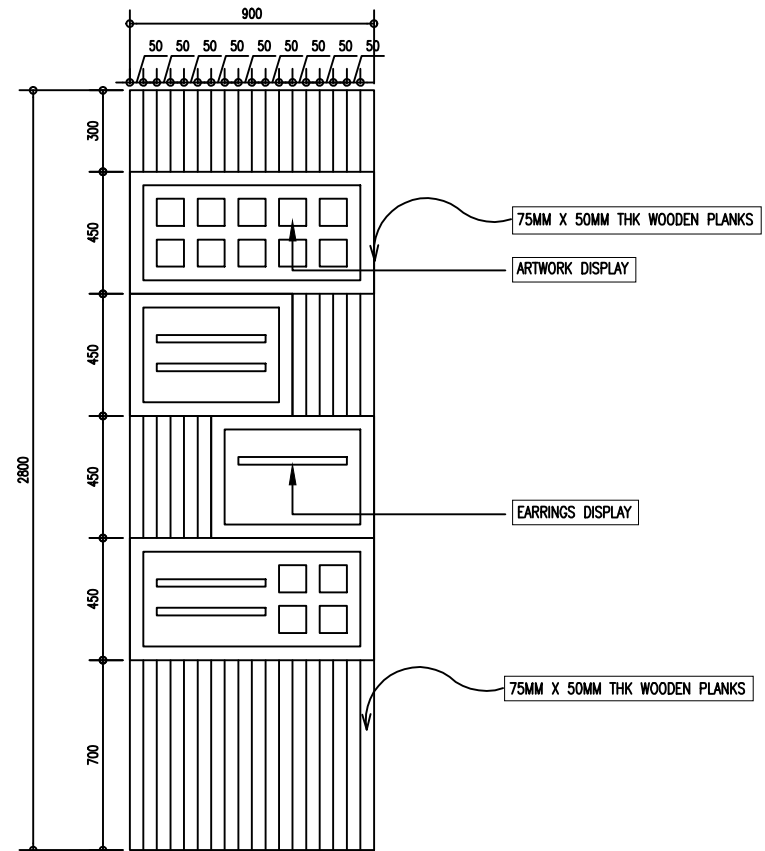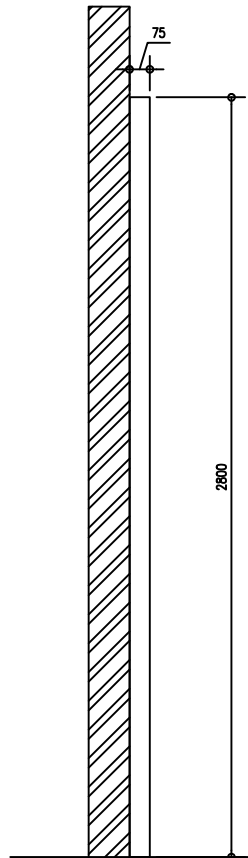

ELEVATION - WALL DISPLAY

SCALE 1:20

CONTRACTORS MUST CHECK ALL DIMENSIONS ON SITE BEFORE STARTING ANY WORK OR SHOP DRAWINGS. FIGURED DIMENSIONS TO TAKE PRECEDENCE OVER SCALE READINGS

REVISION:	ARCHITECT: -	PROJECT: PROPOSED AUTHENTIC MALDIVES OUTLET @ AA, THODDOO	ID-11
	ENGINEER: -	LOCATION: AA, THODDOO, MALDIVES	
	ARC. CHECKER: -	DRAWING TITLE: AS GIVEN	DWG NO
	STR. CHECKER: -	CLIENT: -	PROJECT NO: 23-000
	DRAWN BY: ASFAN AHMED	SCALE: AS GIVEN DIMENSION: MM DATE: MARCH 2023	



VIEW - 1



VIEW - 3