

 



 
 


PROPOSED SINGLE STOREY FARMER'S MARKET


AA.THODDOO

MEP DRAWINGS

JULY 2023

ACMV LEGEND

SYMBOL	DESCRIPTION
	AIR-CONDITIONING INDOOR UNIT WALL MOUNTED
	AIR-CONDITIONING OUTDOOR UNIT WALL MOUNTED
	EXHAUST FAN WITH AIR FLOW RATE OF 1000 CMH
	INSULATED LIQUID PIPE
	INSULATED GAS PIPE
	INSULATED DRAIN PIPE
	ABOVE TO BELOW
	BELOW TO ABOVE

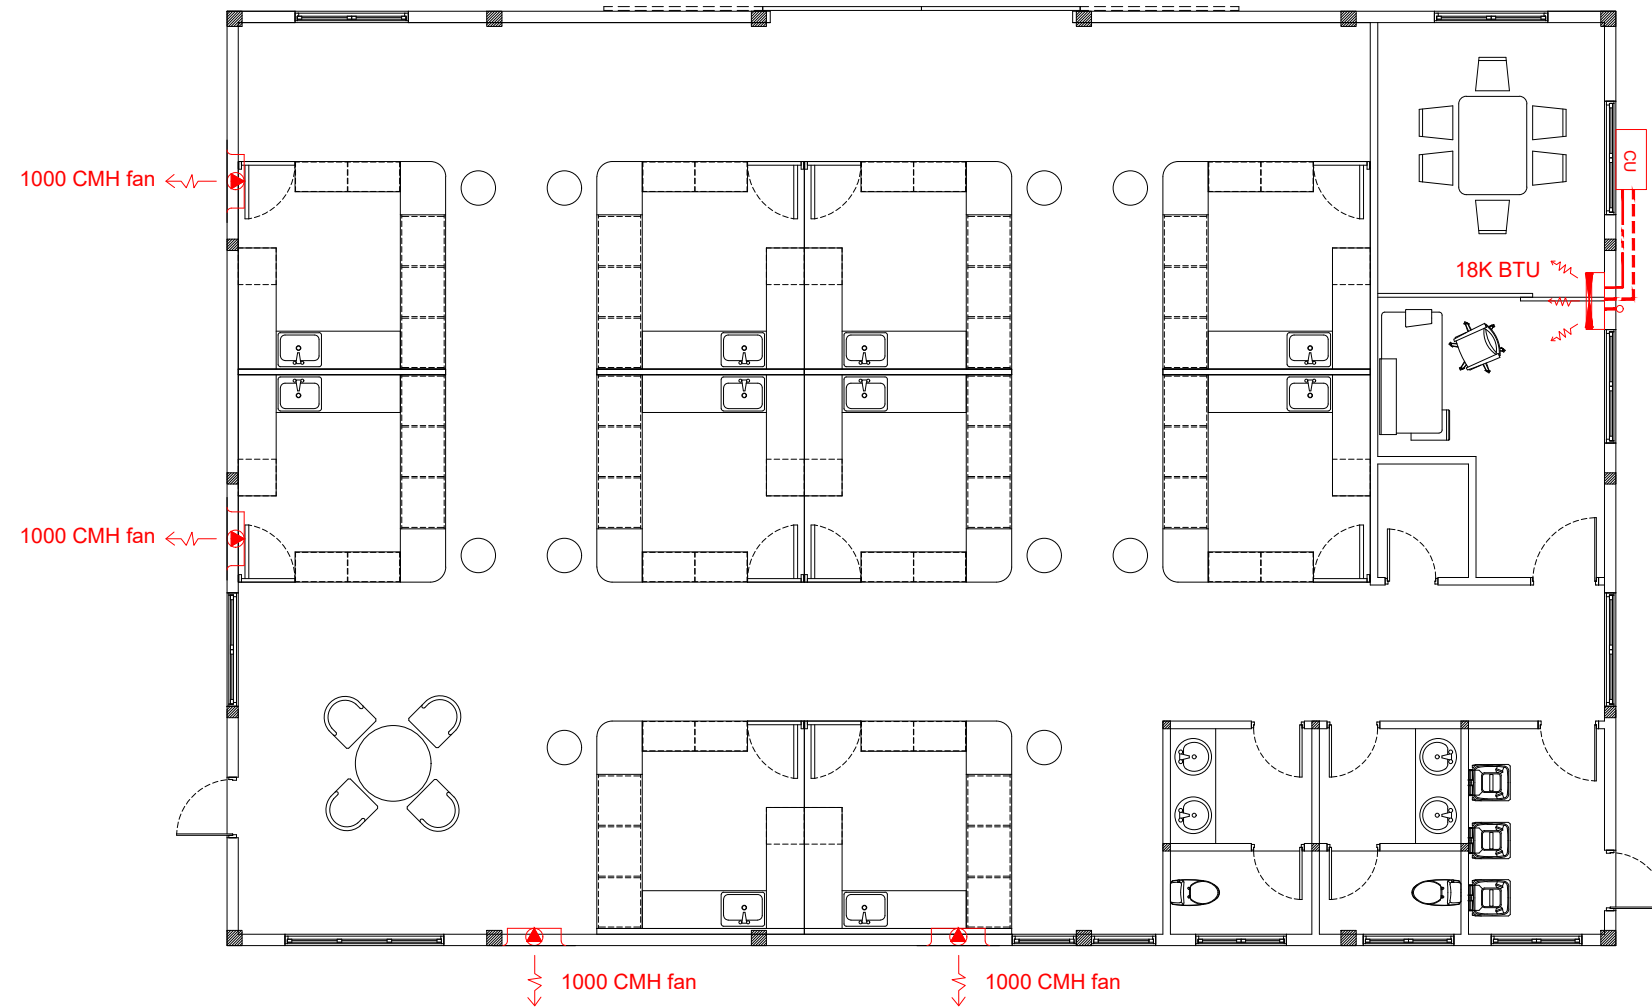

NOTES:
 • DO NOT SCALE THE DRAWING IF IN DOUBT / PLEASE REFER TO THE DIMENSIONS GIVEN
 • ALL DIMENSIONS SHALL BE VERIFIED ON SITE BEFORE EXECUTING THE WORKS.
 • SHOP DRAWINGS SHALL BE APPROVED BEFORE COMMENCING OF CONSTRUCTION OR MANUFACTURING

PROJECT NAME
 PROPOSED SINGLE STOREY FARMER'S MARKET

LOCATION
 AA.THODDOO

BUILDING TYPE
 COMMERCIAL

CLIENT
 BCC

ELECTRICAL DRAWING


DRAWN BY	SHAHEED
DESIGNED BY	-
CHECKED BY	-

KEY PLAN

REV	DESCRIPTION	DATE









DRAWING TITLE AS GIVEN	SCALE AS GIVEN
SHEET SIZE A3	DRAWING NO E-2.03
DATE JULY 2023	


01 GROUND FLOOR ACMV PLAN
 SCALE 1:100



DISCLAIMER : THIS DRAWING IS A PROPERTY OF THE DESIGN TEAM. UNAUTHORIZED USE OF ANY KIND OF COPYING OF THE WHOLE OR PART OF THIS DRAWING IS PROHIBITED.

SANITARY LEGEND

SYMBOL	DESCRIPTION
	SEWER LINE
	VENT LINE
	FLOOR TRAP
	GREASE TRAP
	CLEANING EYE
	INSPECTION CHAMBER
	ABOVE TO BELOW
	BELOW TO ABOVE

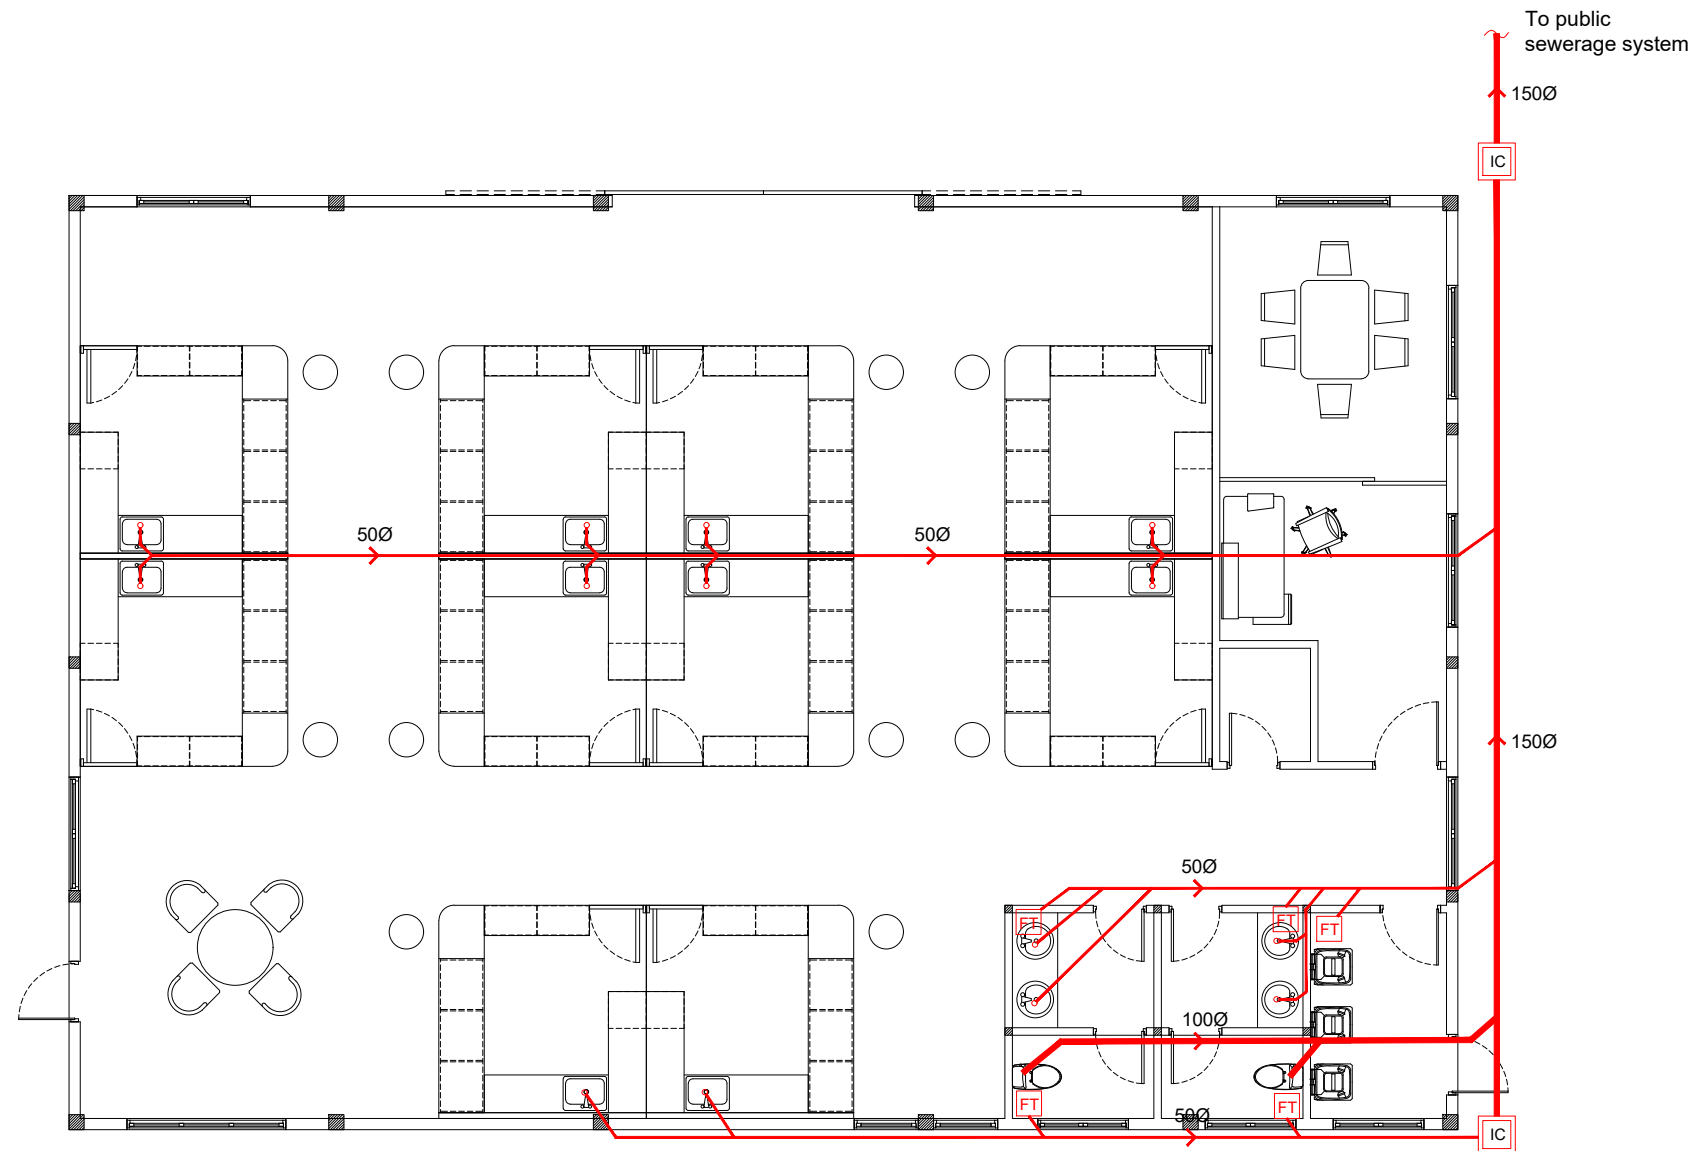

NOTES:

- DO NOT SCALE THE DRAWING IF IN DOUBT / PLEASE REFER TO THE DIMENSIONS GIVEN
- ALL DIMENSIONS SHALL BE VERIFIED ON SITE BEFORE EXECUTING THE WORKS.
- SHOP DRAWINGS SHALL BE APPROVED BEFORE COMMENCING OF CONSTRUCTION OR MANUFACTURING

PROJECT NAME
PROPOSED SINGLE STOREY FARMER'S MARKET

LOCATION
 AA.THODDOO

BUILDING TYPE
 COMMERCIAL

CLIENT
 BCC

PLUMBING DRAWING

DRAWN BY SHAHEED

DESIGNED BY -

CHECKED BY -

KEY PLAN

REV	DESCRIPTION	DATE

DRAWING TITLE AS GIVEN	SCALE AS GIVEN
SHEET SIZE A3	DRAWING NO P-2.02
DATE JULY 2023	

01 GROUND FLOOR SANITARY PLAN
 SCALE 1:100



DISCLAIMER : THIS DRAWING IS A PROPERTY OF THE DESIGN TEAM. UNAUTHORIZED USE OF ANY KIND OF COPYING OF THE WHOLE OR PART OF THIS DRAWING IS PROHIBITED.