




Askani front view

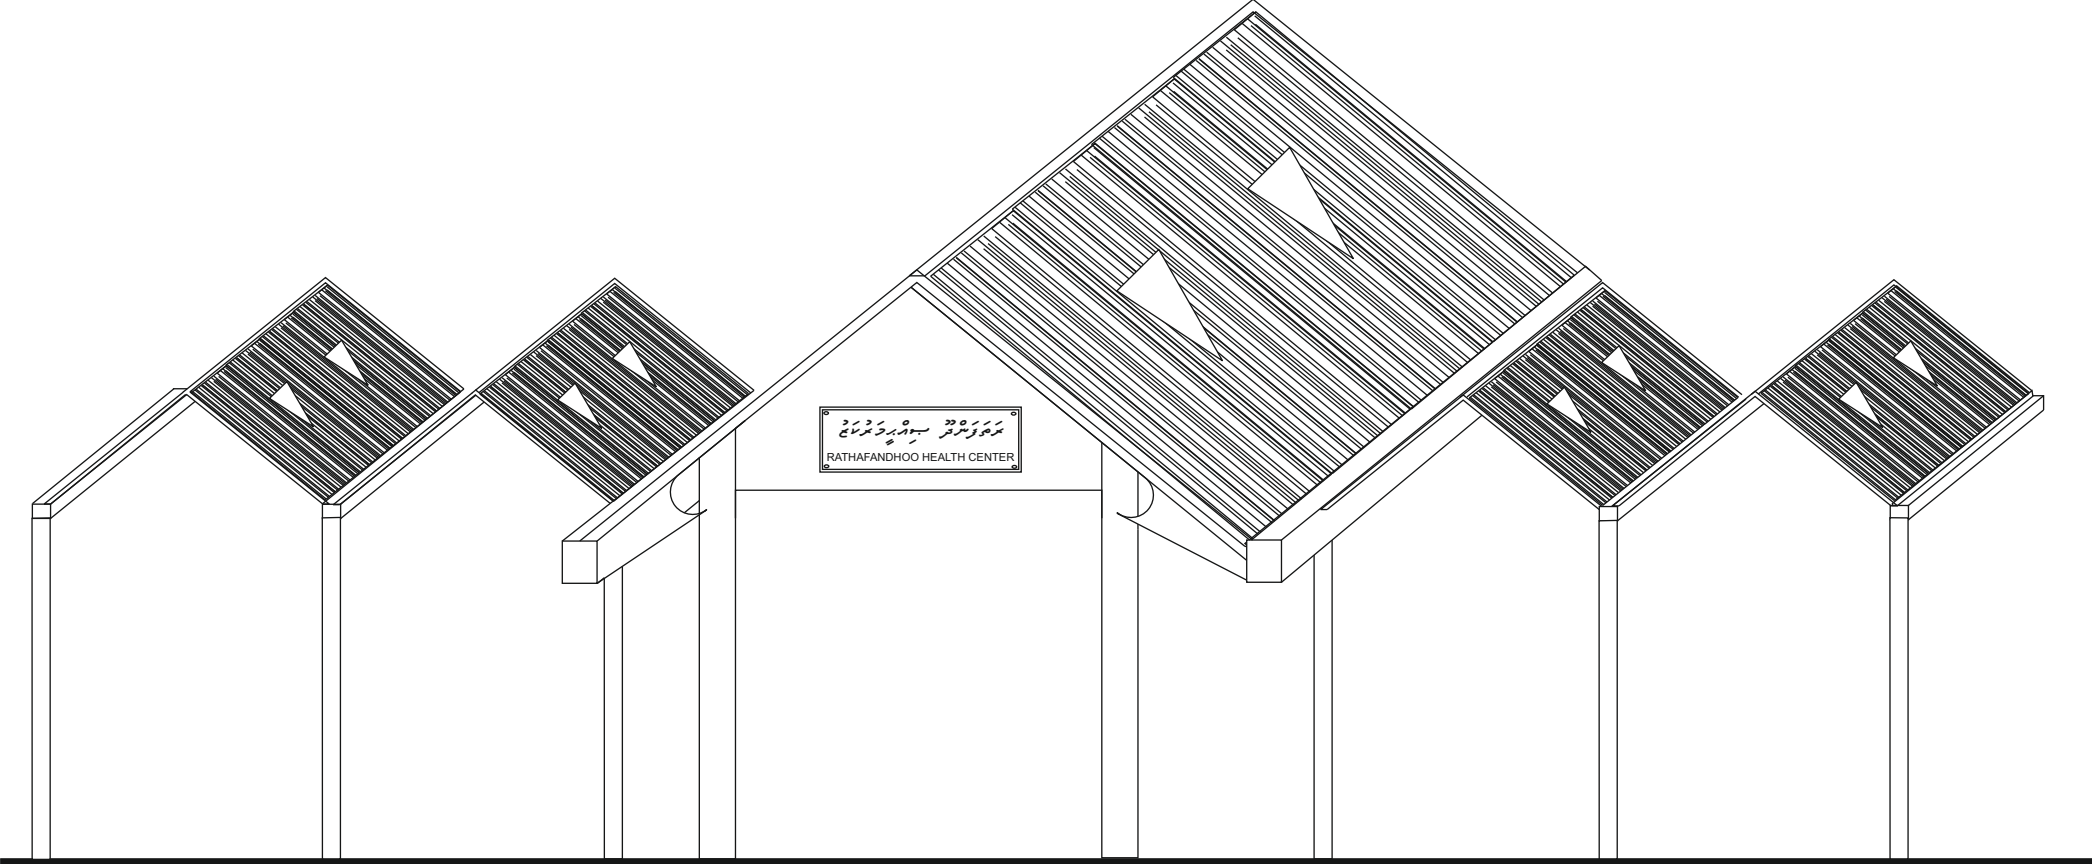


# Ground floor plan (Askani)

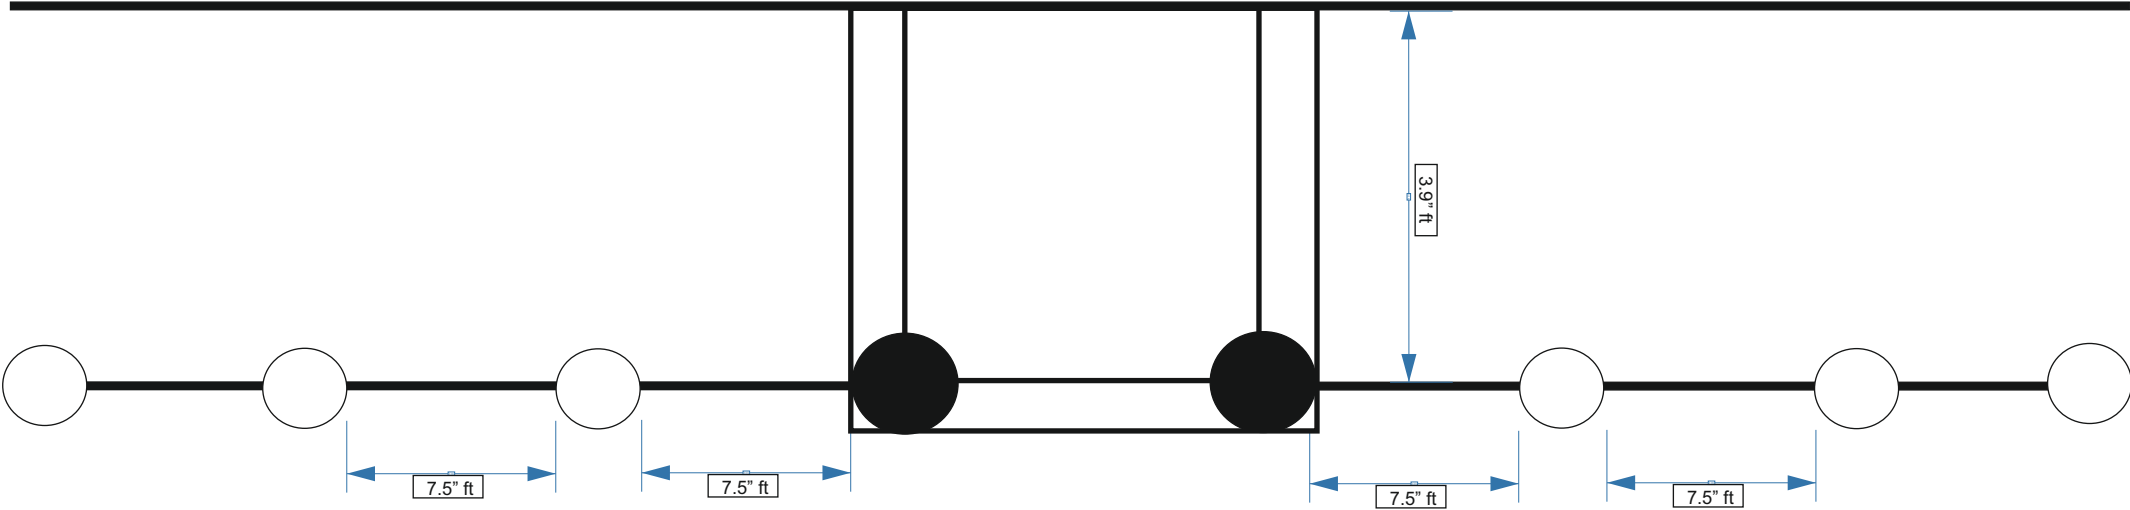


# Roof plan

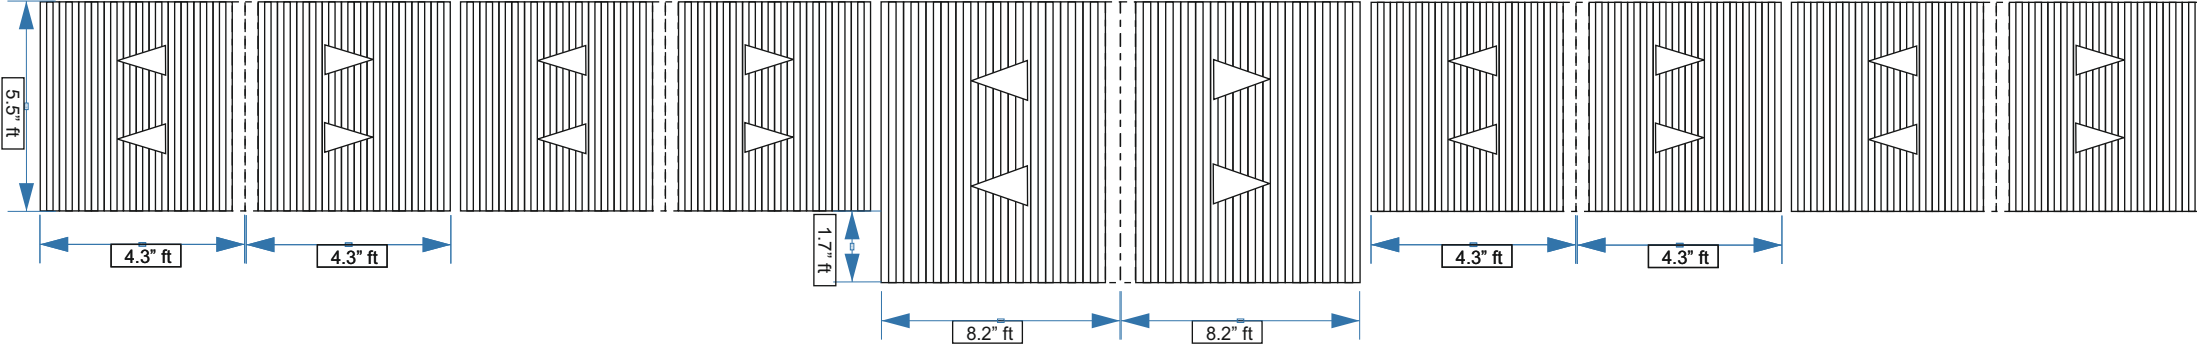

# Side view of concrete Piller and beam (Askani)

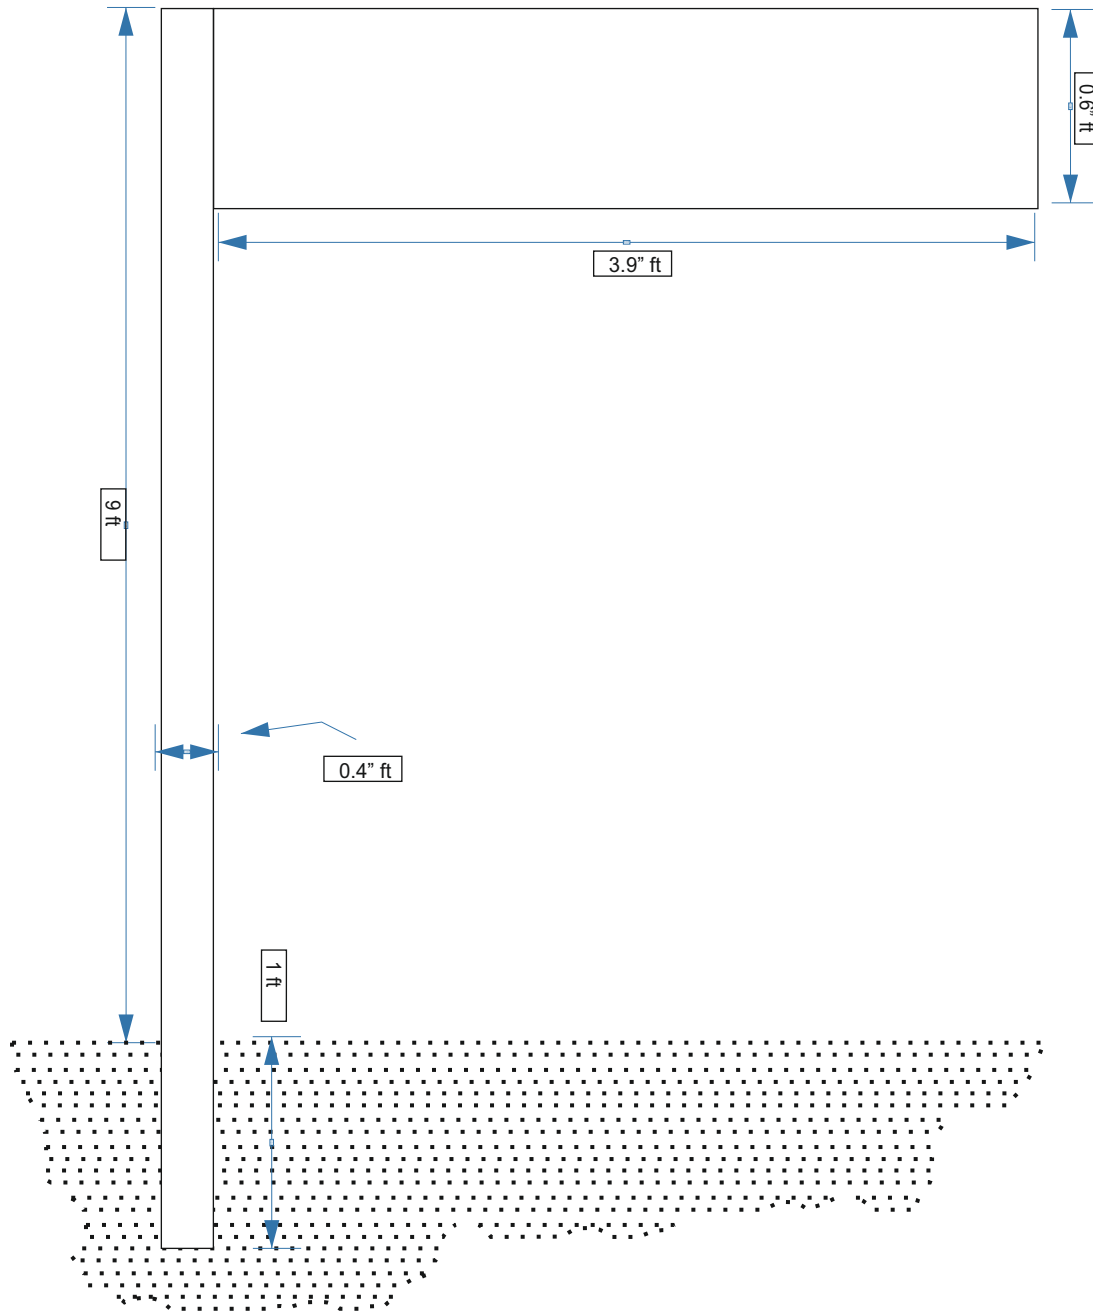


# Top view of Piller and beam

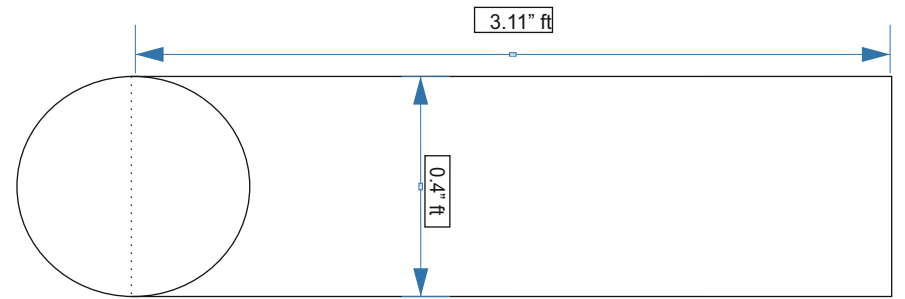


# Askani


## Beam details

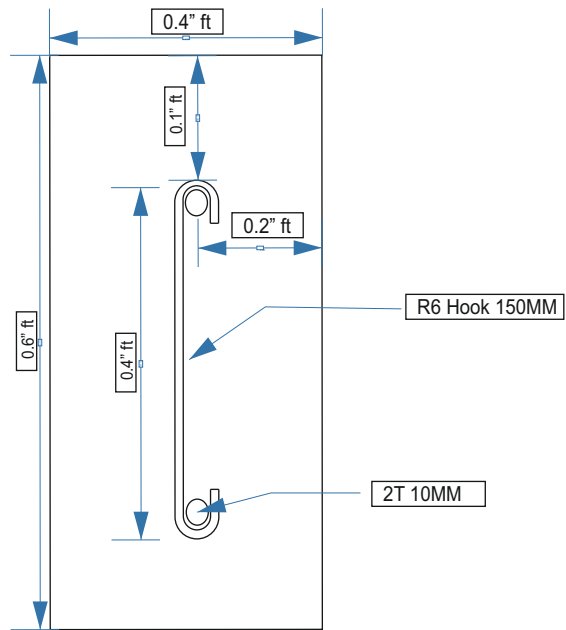

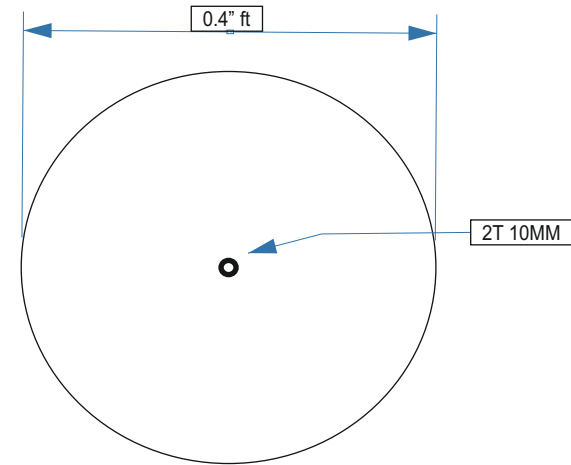

## Pill details

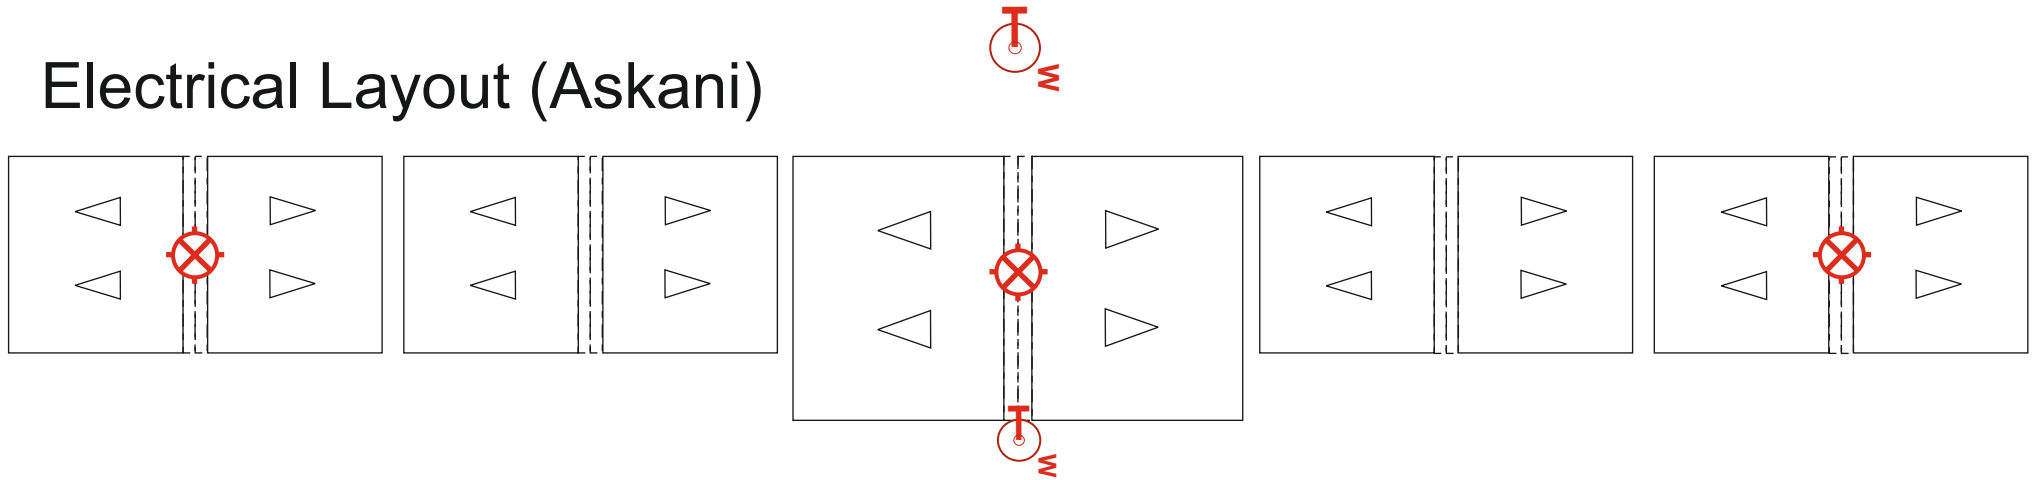

# Electrical Layout (Askani)




-  Ceiling mount light
-  Weather proof wall mount light




# Pertition details


Lab and dressing room

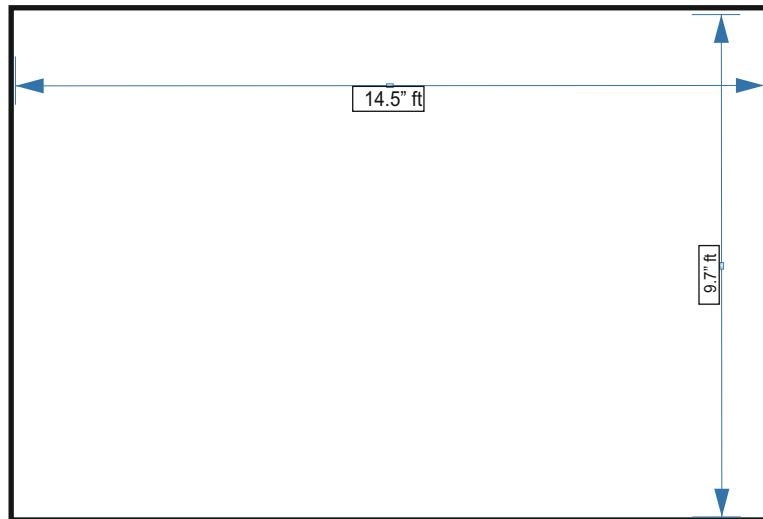

Hall and consultation room

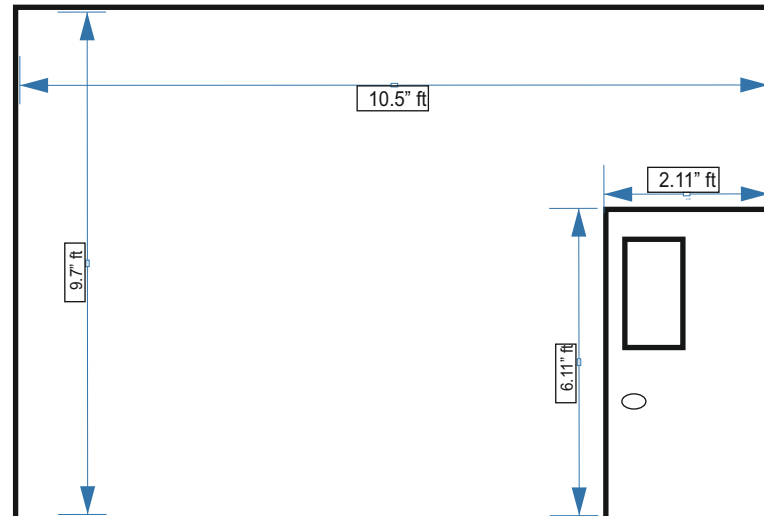

# Health Center Roof plan

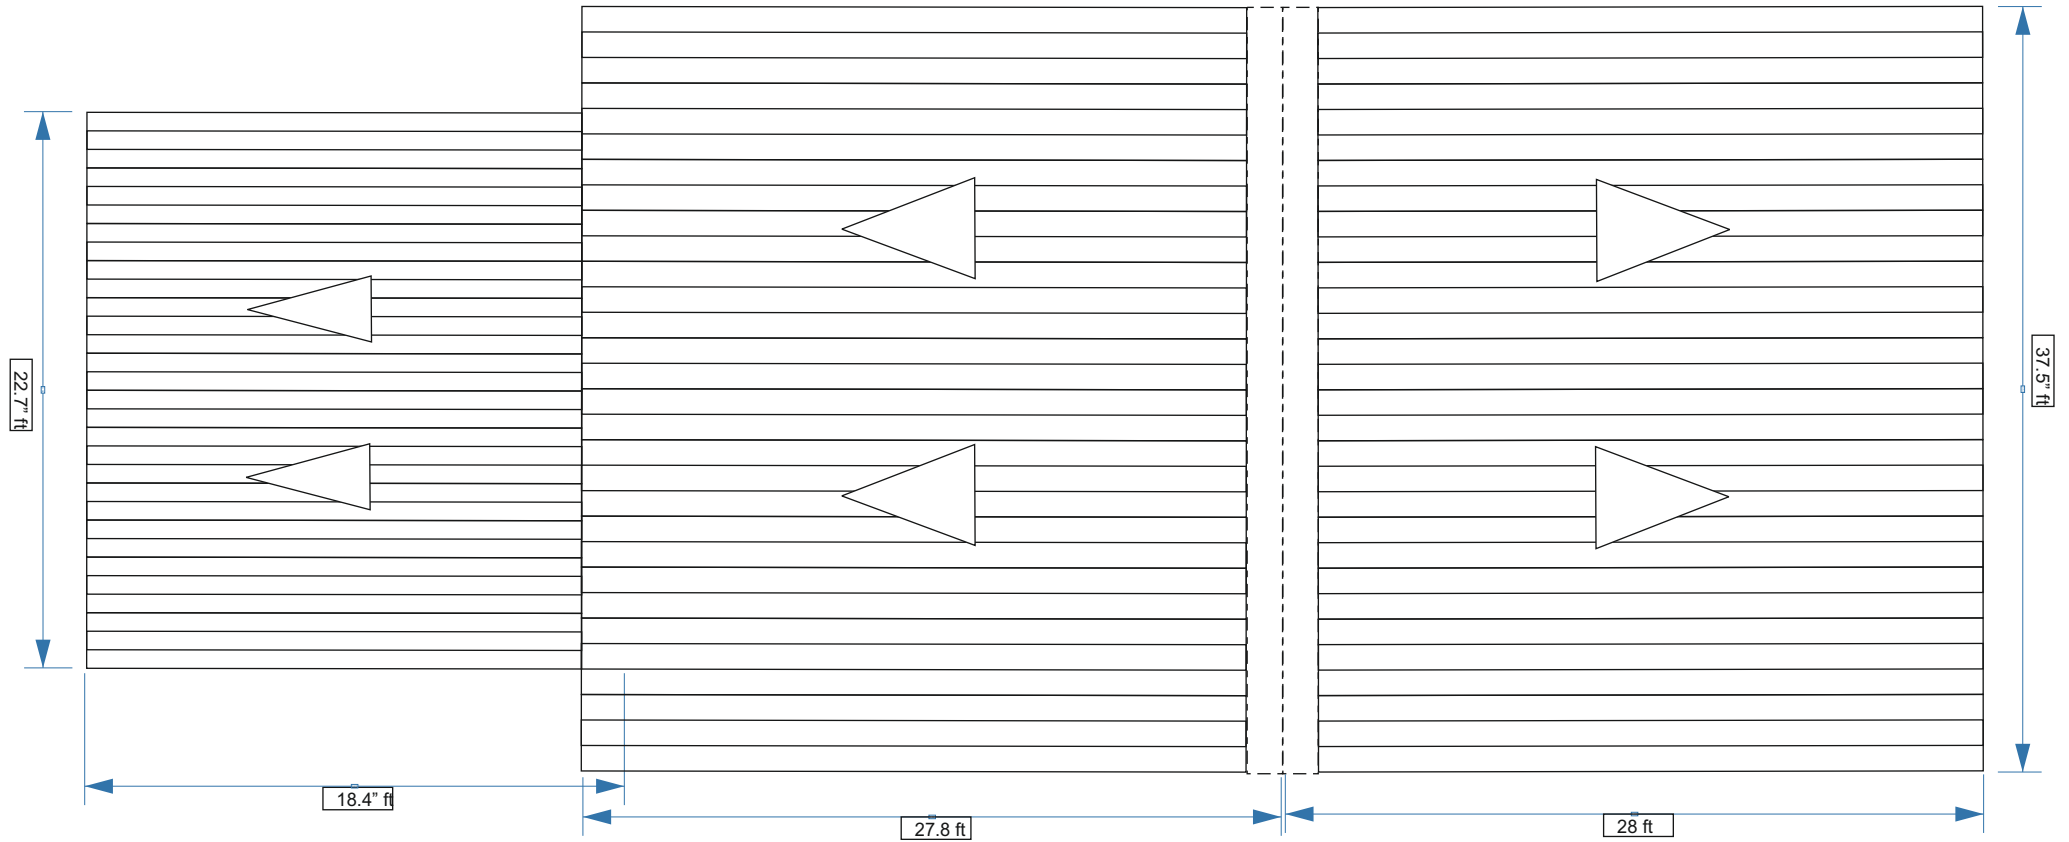



# DOORS AND WINDOWS SCHEDULE

Scale 1:50

SYMBOL	D1	D2	DL1
ELEVATION			
LOCATION	GROUND FLOOR	GROUND FLOOR	GROUND FLOOR
DESCRIPTION	40MM THICK TOP HUNG DOOR	40MM THICK OPENABLE ALUMINUM FRAMED DOOR	40MM THICK OPENABLE ALUMINUM FRAMED DOOR
FRAME	120MM ALUMINUM FRAME 80 MICRON POWDER COATED, BLACK SANDY GRAY	120MM ALUMINUM FRAME 80 MICRON POWDER COATED, BLACK SANDY GRAY	120MM ALUMINUM FRAME 80 MICRON POWDER COATED, BLACK SANDY GRAY
HARDWARE	DOOR CLOSER DEAD LOCKS BUTT HINGE STOPPER HOLDER LONG DOOR HANDLE ON BOTH SIDE, MIN 750MM	DOOR CLOSER HANDLE LOCK BUTT HINGE STOPPER HOLDER KICKER	DOOR CLOSER HANDLE LOCK BUTT HINGE STOPPER HOLDER KICKER
GLAZING	C-6MM ALL FIXED PANELS TO BE DOUBLE GLAZED	C-6MM ALL FIXED PANELS TO BE DOUBLE GLAZED	C-6MM ALL FIXED PANELS TO BE DOUBLE GLAZED
NOTE	ALL MEASUREMENTS TO BE CHECKED ON SITE	ALL MEASUREMENTS TO BE CHECKED ON SITE	ALL MEASUREMENTS TO BE CHECKED ON SITE

