

- Legend**
- Refrigerant Pipes
 - 25Ø Condensate Drain Pipe
 - 40Ø Condensate Drain Riser Pipe
 - Wall Mounted Exhaust Fan
 - Wall Mount Air Conditioner
 - 4-Way Cassette Air Conditioner
 - Outdoor Condensing Unit
 - 15A Switched Socket @ H.L.

Notes:-

Where Condensate Drain Pipes Are Connected To Wash Basin Or Kitchen Sink, 25 Ø Condensate Drain Pipe Is Extended In 32 Ø Flex Conduit Into 40 Ø Waste Pipe Of Respective Basin Or Sink

General Notes:

Rev no	Date
-	-
-	-
-	-

Proposed Single Storey Building at Council Building
Client: Local Government Authority (LGA)
 Project Number: A/2023/038
 Date: 18 June 2023
 Architect : ABDUL WAHID MOHAMED
 Engineer : -
 Drawn by : ISMAIL RAFAEEL
 Services : NASHEED
 Interior : -




ARCON PRIVATE LIMITED
 T : +963320203, M : +963792023
 W : www.arcon.com.om
 Ground Floor, Al-Sayer Highway,
 Sabkhat Al-Muqaybiyah

Title: ACV LAYOUT
 Page: SV - 01/07

GROUND FLOOR ACV LAYOUT

1:100

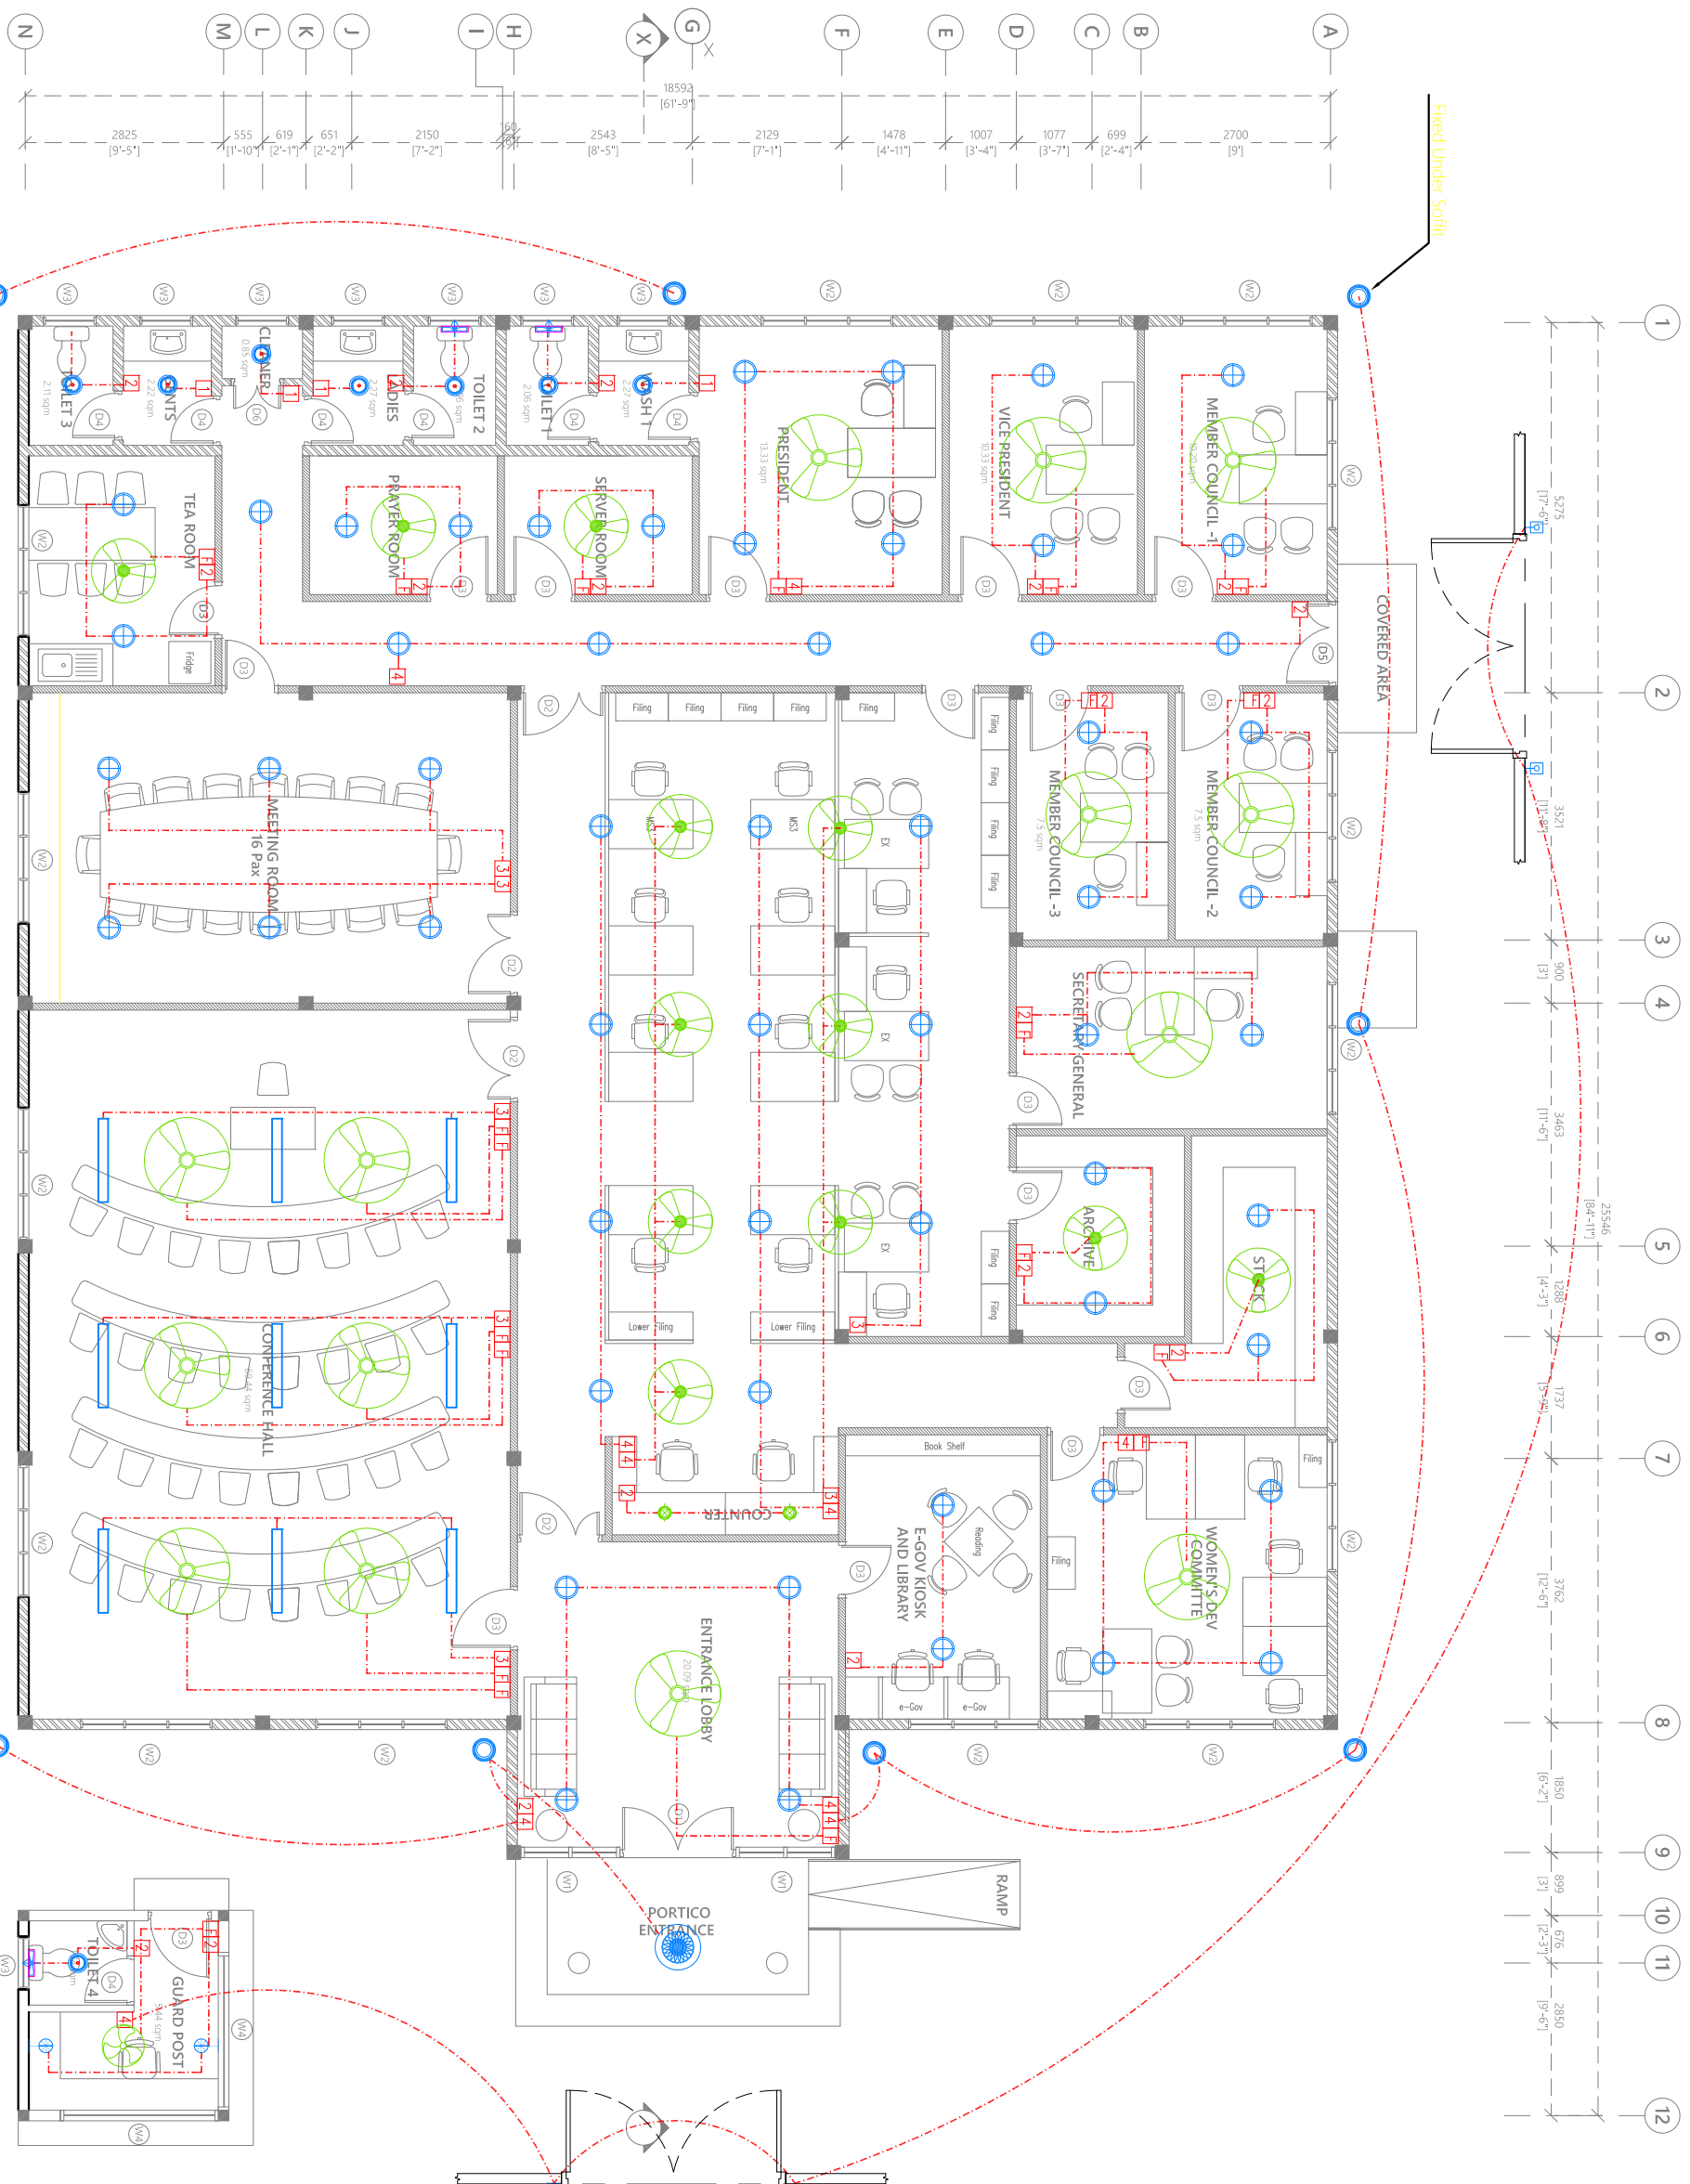

Fixed Under Soffit

Legend

- Ceiling Light (12W)
- Recessed Ceiling Light (12W)
- Ceiling Down Light (18W) - Weather Proof
- 150 X 1200 Ceiling Recessed LED Panel
- Indoor Wall Light (18W)
- Outdoor Lamp (12W)
- Decorative Pendant Light
- Ceiling Mount Spot Light (5W)
- Light Switch (1 Gang - 4 Gang)
- Ceiling Fan Switch With Controller
- 29" To 36" Ceiling Fan
- 42" To 48" Ceiling Fan
- Wall Mounted Exhaust Fan
- Oscillating Ceiling Fan

Note:
Distance to Gate and Guard Post to be determined based on measurements shown on Site Plan.

General Notes:




Rev no	1	2	3	4
Date				
Drawn by				
Checked by				
Approved by				

Proposed Single Storey Building at Council Building
 Client: Local Government Authority (LGA)
 Project Number: A/2023/038
 Date: 18 June 2023
 Architect: ABDUL WAHID MOHAMED
 Engineer: -
 Drawn by: ISMAIL RAFAEEL
 Services: NASHEED
 Interior: -

ARCON PRIVATE LIMITED
 P.O. Box 12003, m: +9687792023
 W: www.arcon.com.om
 Ground Floor, Al-Salwa Highway,
 Sohar, Muscat, Sultanate of Oman

GROUND FLOOR LIGHTING LAYOUT
 1:100

The contents of these drawings remain as a property of Arcon Private Limited. Any use other than those expressly stated is a violation of this copyright.

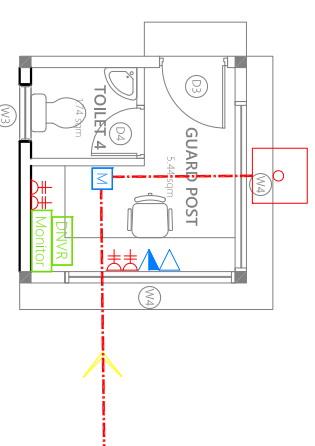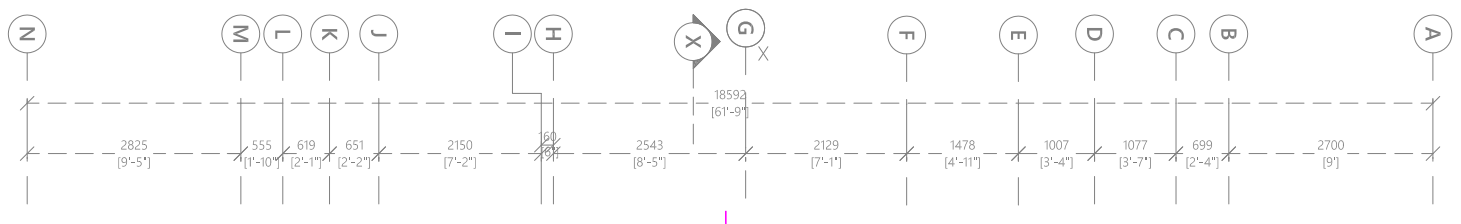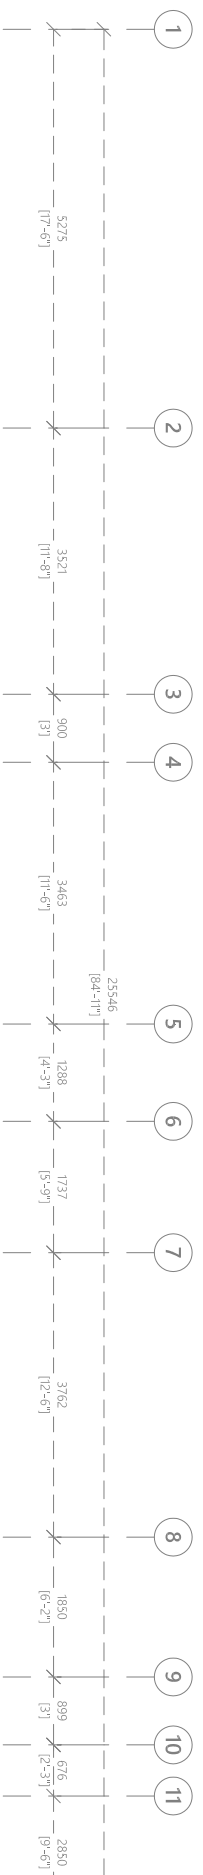

Legend

- 13A Twin Socket
- 13A Twin Socket with USB Ports
- 13A Power Socket
- 15A Switched Socket @ H.L.
- 15A Socket in Polycarbonate Box
- Distribution Board
- High Level
- Angular Camera
- Security Monitor
- Digital/network Video Recorder
- Telephone Outlet
- Telephone Extension
- Computer Network Outlet
- Emergency Light
- Wall Mounted Speaker
- VGA Inlet Socket for Ceiling Mounted Projector
- VGA Outlet Socket for Ceiling Mounted Projector
- Electricity Meter
- Internet Switchboard
- Private Automatic Branch Exchange (PABX)
- PVC Duct For Tel/Internet Cable Lead in Below Ground Slab
- PVC Duct For TV Cable Lead in Below Ground Slab
- Main Incoming Cable For Power PVC Duct Below Ground

GROUND FLOOR POWER LAYOUT

1:100

arcon

ARCON PRIVATE LIMITED
 P.O. Box 12003, M. 2907792023
 W. www.arcon.com.lk
 Ground Floor, 4, Sagar Highway,
 Sabarimala, Negombo, Sri Lanka

Proposed Single Storey Building at Council Building
 Client: Local Government Authority (LGA)

Project Number: A/2023/038
 Date: 18 June 2023
 Architect: ABDUL WAHID MOHAMED
 Engineer: -
 Drawn by: ISMAIL RAFAEEL
 Services: NASHEED
 Interior: -




General Notes:

Rev no	Date
-	-
-	-
-	-

Title: POWER LAYOUT

Page: SV - 03/07

The contents of these drawings remain as a property of Arcon Private Limited. Any use other than those expressly stated is a violation of this copyright

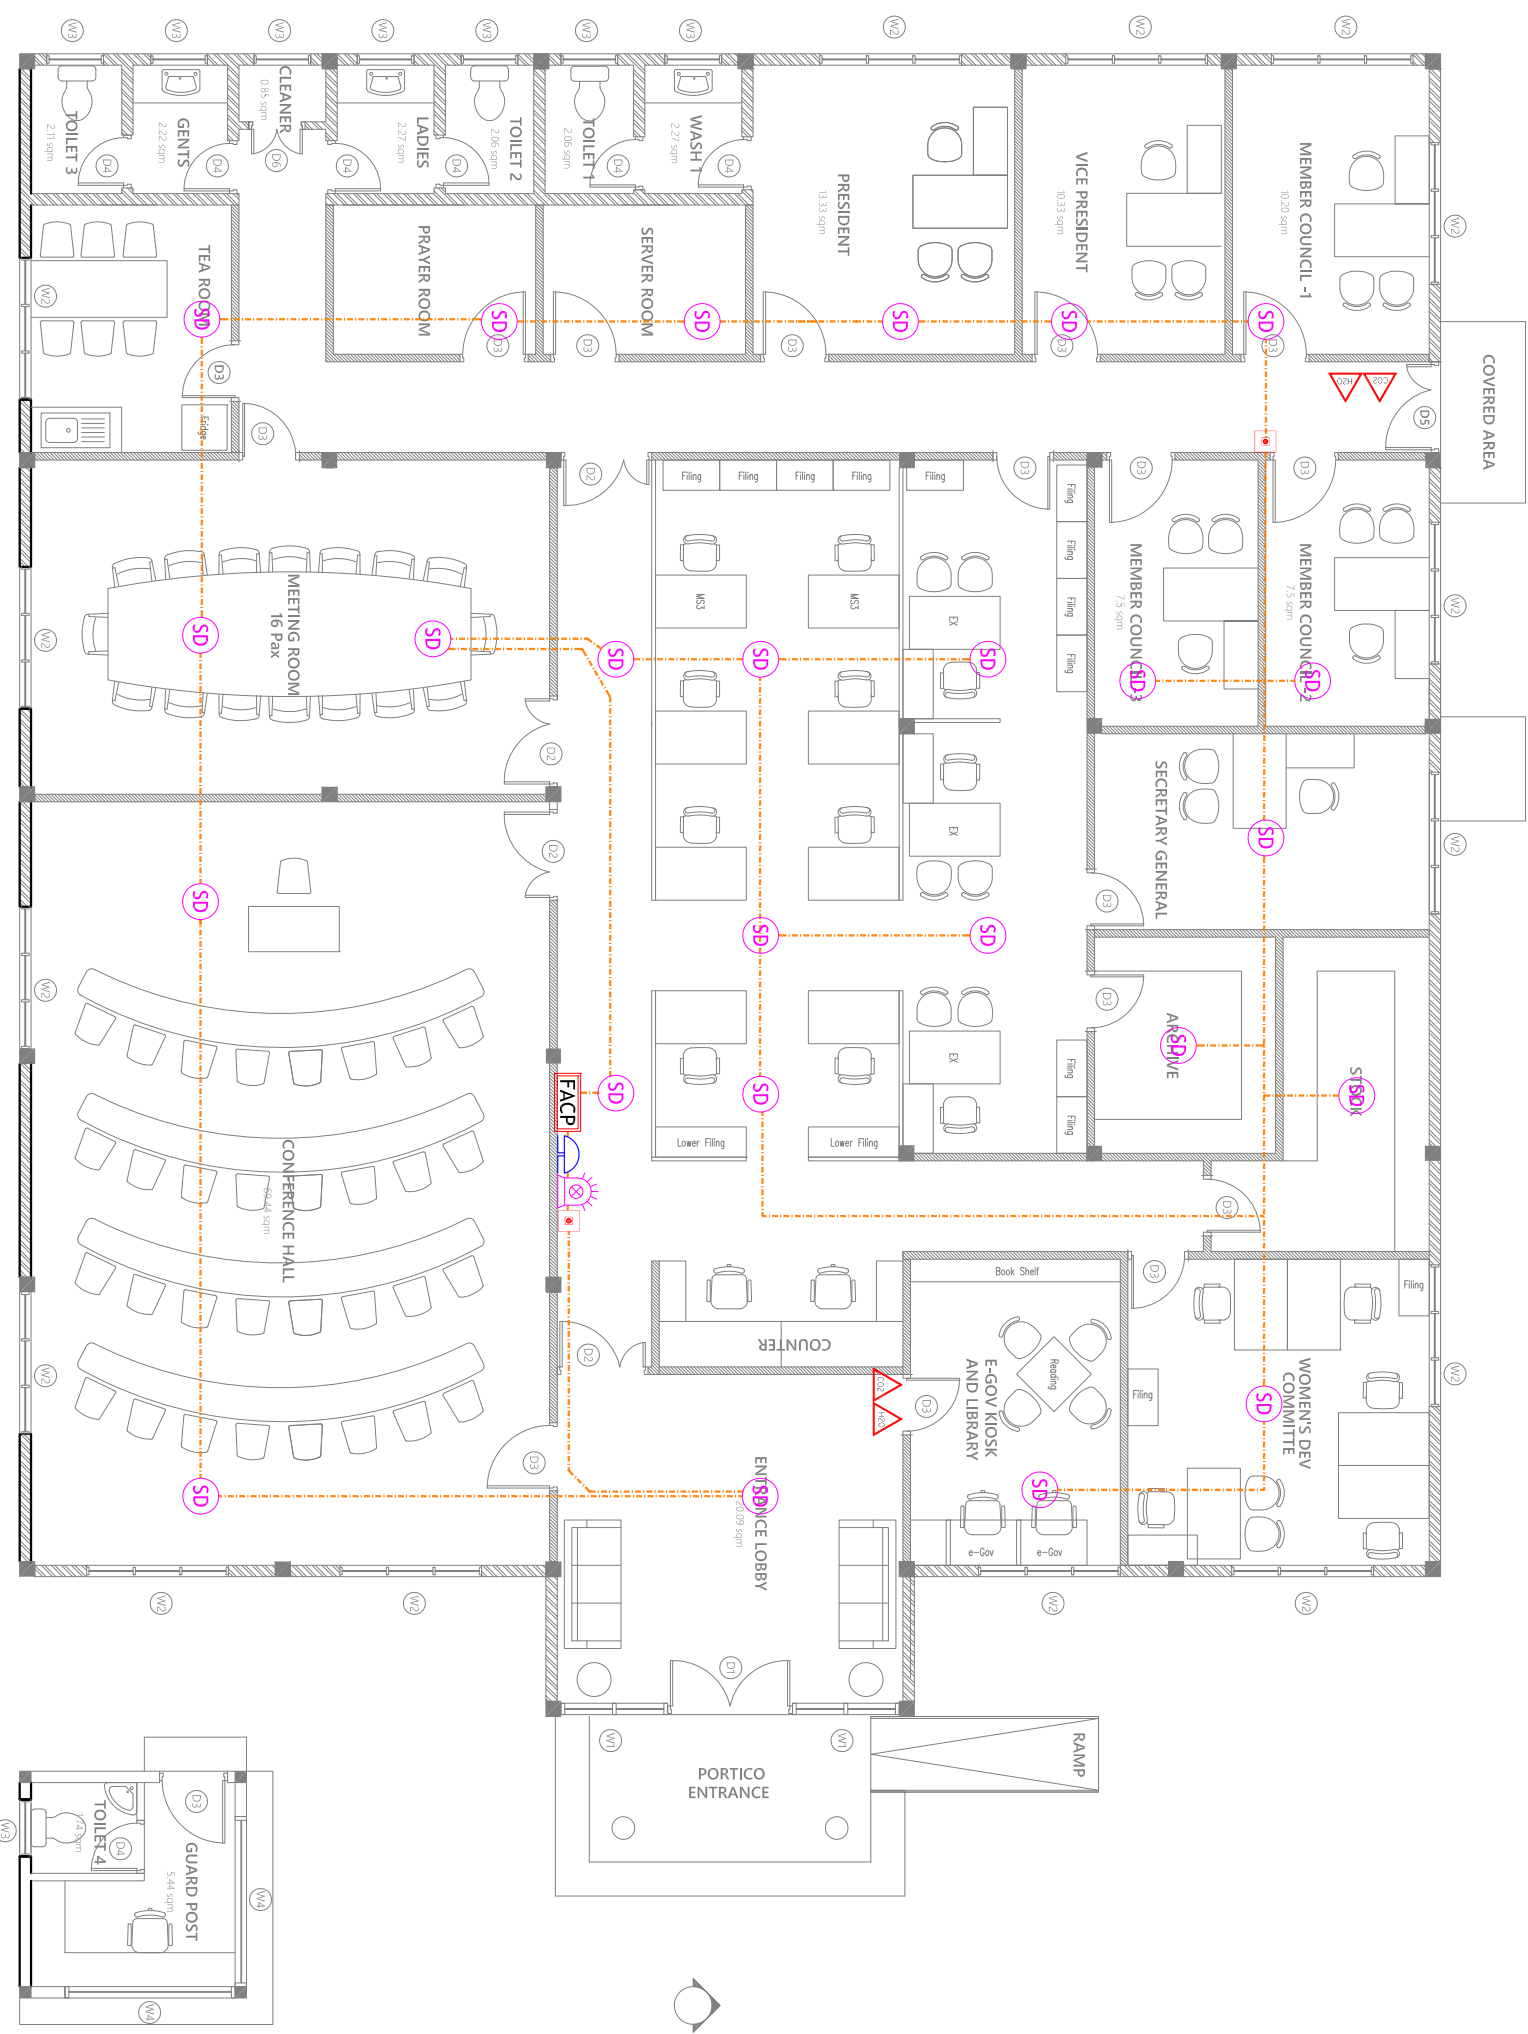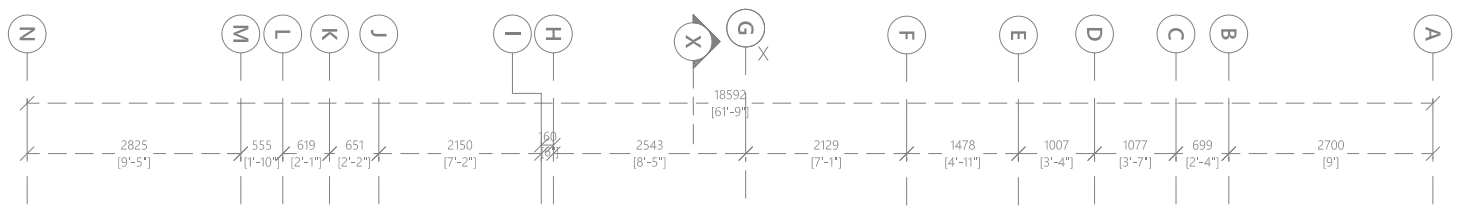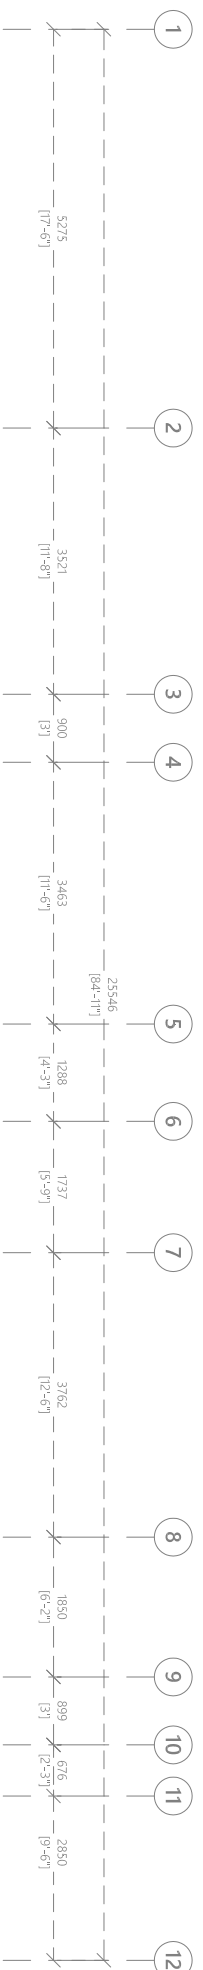

- Legend**
- CO₂ Extinguisher (load: 2kg) In Polycarbonate Enclosure
 - H₂O Extinguisher (load: 9L) In Polycarbonate Enclosure
 - Manual Call Point
 - Smoke Detector
 - Beacon
 - Sounder Bell
 - 2.5mm² Fire Retardant Low Smoke (FRLS) Cables In FRLS Conduits
 - Fire Alarm Control Panel

- 1. ALL DRY RISER PIPES SHOULD BE GALVANIZED, SCHEDULE 40.
- 2. ALL DRY RISER PIPES SHALL BE PAINTED IN RED AS PER REGULATION.
- 3. ALL SUPPORT / BRACKET SHALL BE HOT DIPPED GALVANIZED.

GROUND FLOOR FDP LAYOUT
1:100


arcon
ARCON PRIVATE LIMITED
P.O. Box 12003, m: +9687920283
www.arcon.com.om
Ground Floor, Al-Sayid Highway,
Sobhanah, Muscat, Oman

Proposed Single Storey Building at Council Building
Client: Local Government Authority (LGA)
Project Number: A/2023/038
Date: 18 June 2023
Architect: ABDUL WAHID MOHAMED
Engineer: -
Drawn by: ISMAIL RAFAEEL
Services: NASHEED
Interior: -

General Notes:

Rev no	Date
-	-
-	-
-	-

The contents of these drawings remain as a property of Arcon Private Limited. Any use other than those expressly stated is a violation of this copyright

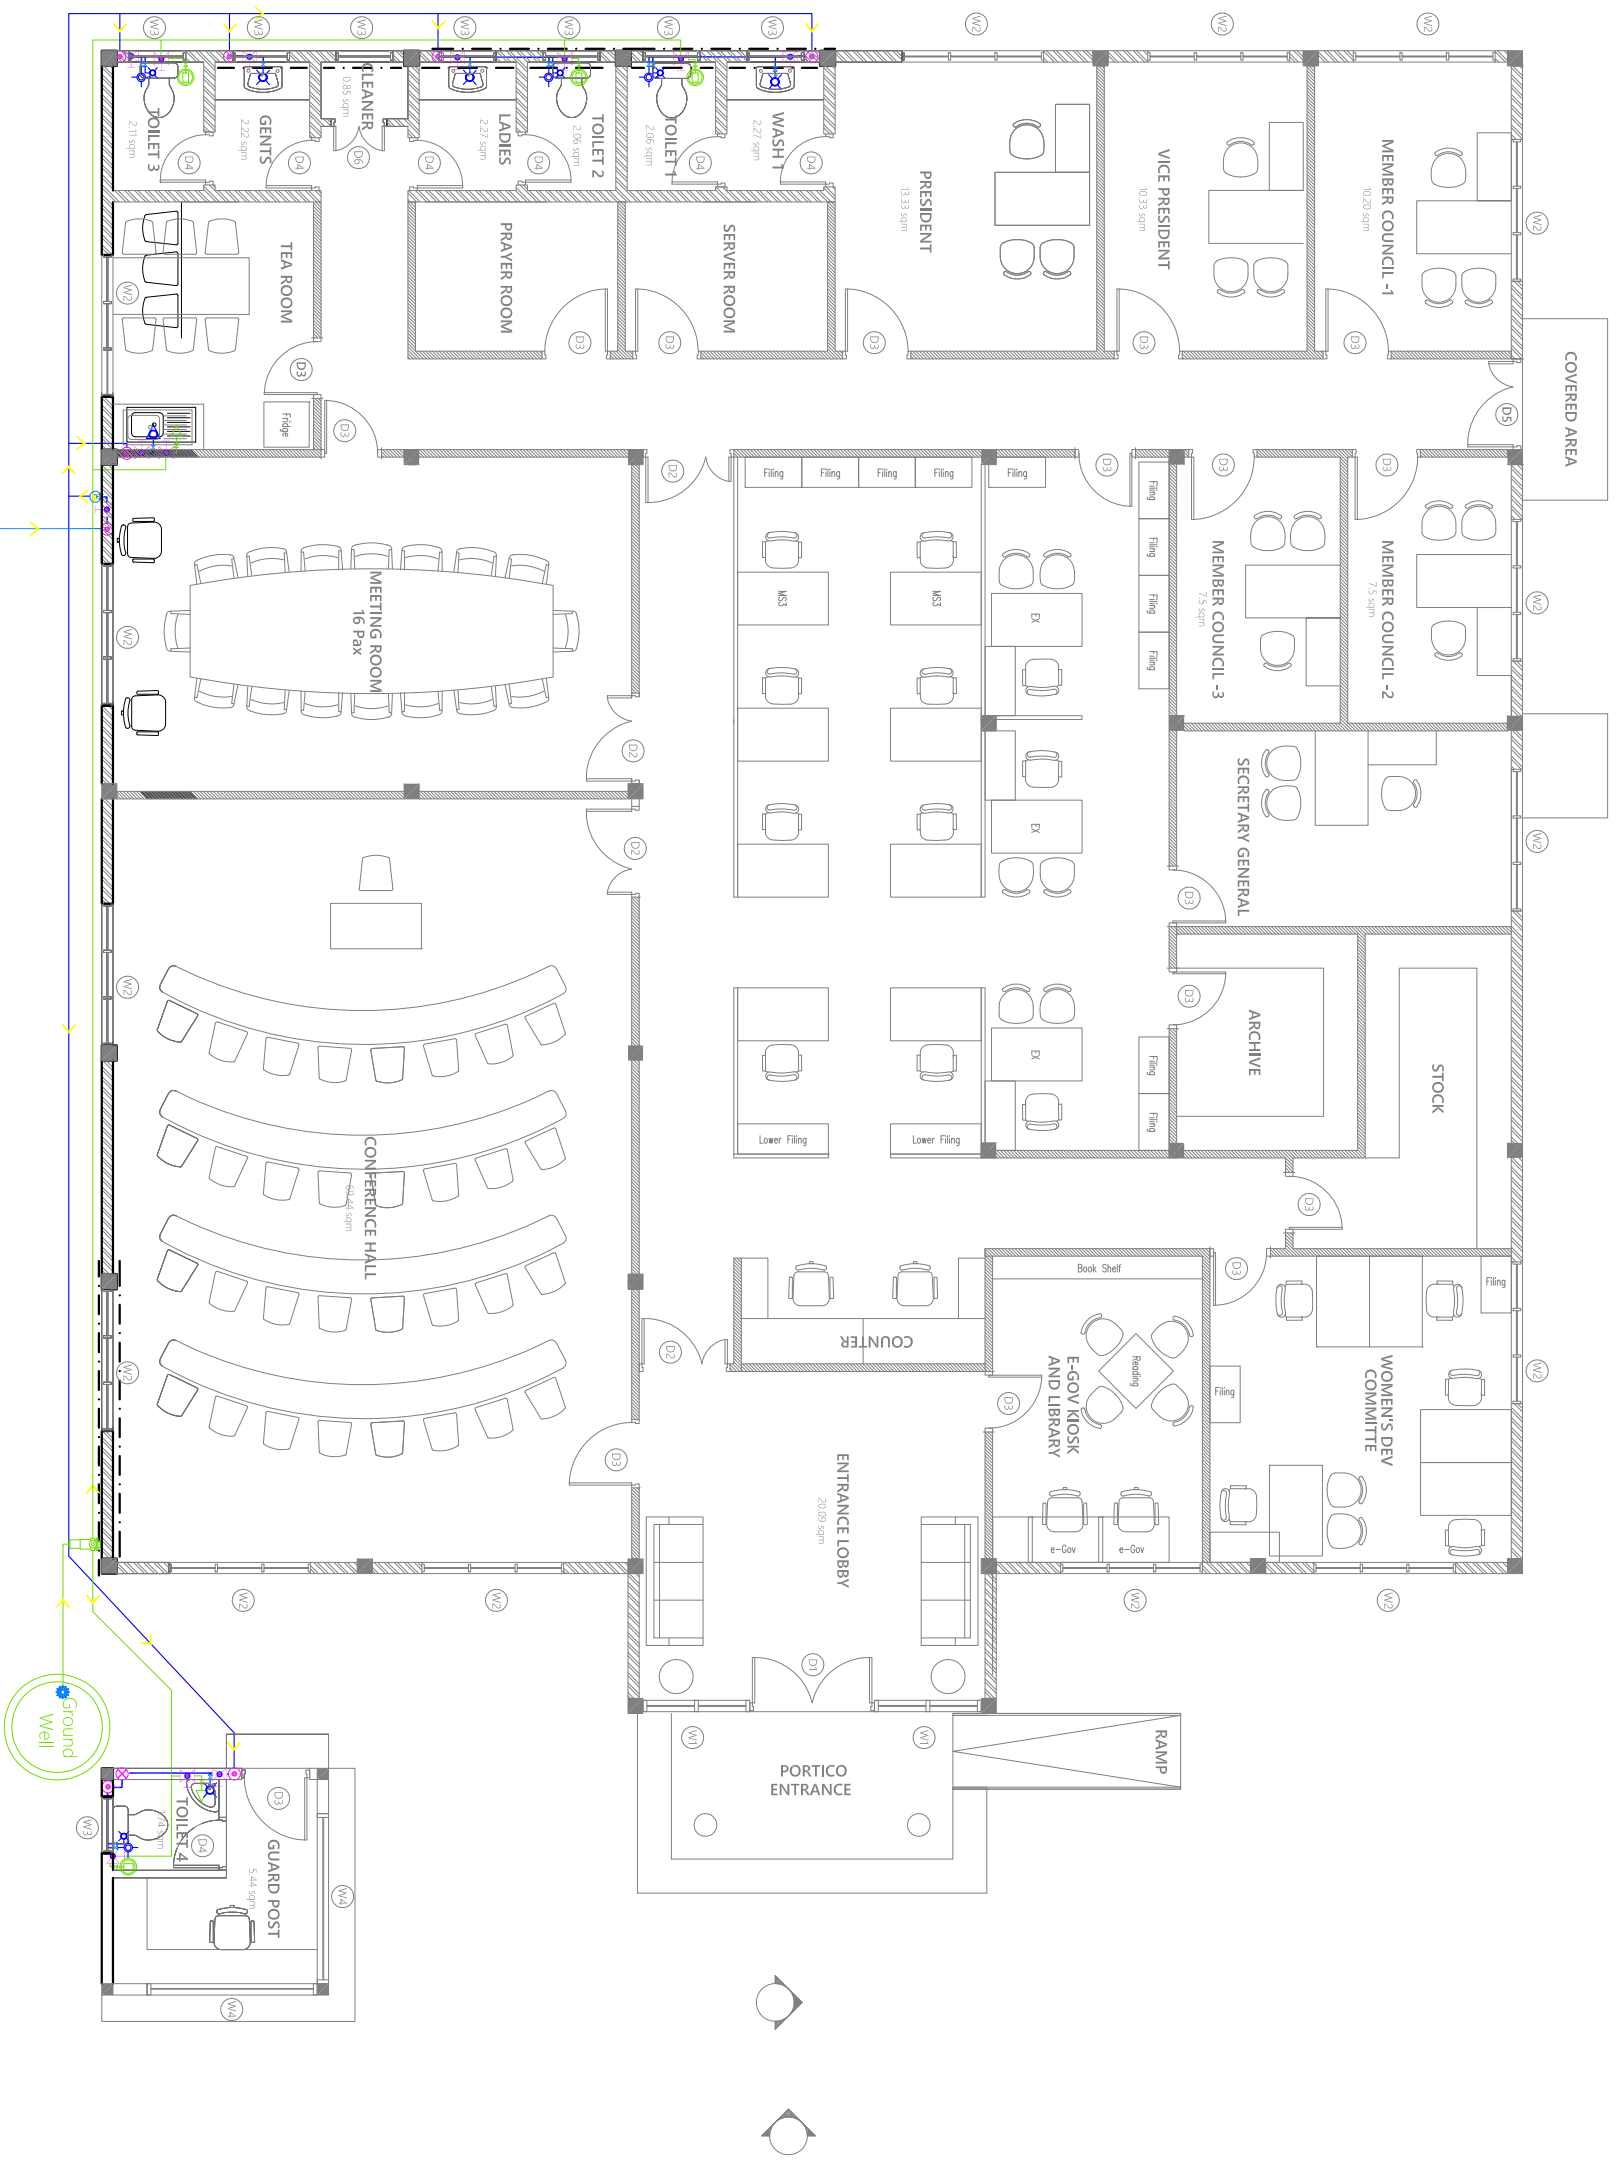


- Legend**
- 16Ø Cold Water Supply To Basin Faucet
 - 16Ø Cold Water Supply To Sink Tap
 - 16Ø Cold Water Supply To Bidet Shower
 - 16Ø Cold Water Supply To Cistern
 - Gate Valve
 - Rise In Wall
 - Drop In Wall
 - MW/SC/FENAKA Meter
 - 20Ø Cold Water Supply Pipes Running Underground
 - 20Ø Cold Water Supply Pipes Running In Wall
 - 20Ø Cold Water Supply Pipes Running Underground
 - 20Ø Ground Water Supply (GWS) Pipe
 - Foot Valve With Strainer
 - Well Water Pump
 - 16Ø Ground Water Supply To Sink Tap
 - 16Ø Ground Water Supply To Cistern

PIPE FROM MAINS SUPPLY

GROUND FLOOR PLUMBING LAYOUT

1:100



ARCON PRIVATE LIMITED
 T: +969320203, M: +969792023
 W: www.arcon.com.lk
 Ground Floor, 41, Sagar Highway,
 Sabarimala Margu, Kotte

Proposed Single Storey Building at Council Building
 Client: Local Government Authority (LGA)

Project Number: A/2023/038
 Date: 18 June 2023
 Architect: ABDUL WAHID MOHAMED
 Engineer: -
 Drawn by: ISMAIL RAFAEEL
 Services: NASHEED
 Interior: -

General Notes:

Rev no	Date
-	-
-	-
-	-

The contents of these drawings remain as a property of Arcon Private Limited. Any use other than those expressly stated is a violation of this copyright

Title: PLUMBING LAYOUT

Page: SV - 05/07

PL-01

Note:
Septic Tank will not be required if the island has a sewer system installed.



- Legend**
- Floor Drain
 - Floor Gully
 - 400 Stub For Washing Machine Or Tub
 - 820 Soil Pipe (uPVC Pipe)
 - 820 Soil Vent Pipe (uPVC Pipe)
 - 630 Waste Pipe (uPVC Pipe)
 - 630 Waste Vent Pipe (uPVC Pipe)
 - 400 Waste Pipe (uPVC Pipe)
 - 400 Manhole Vent Pipe (uPVC Pipe)
 - 110 Rain Water Pipes (uPVC Pipe)
 - Gully Trap
 - 1100 Rainwater Outlet
 - Clean Out Point
 - Bottle Trap

Notes:-
-All Drainage Pipes Should Have At A Slope Of 1/150
-All Floor Drains Should Have "P" Traps

GROUND FLOOR DRAINAGE LAYOUT

1:100


ARCON PRIVATE LIMITED
 T: +963520203, M: +963792023
 W: www.arcon.com.nv
 Ground Floor, 4, Solar Highway,
 Suburban Meiga, Nicosia

Proposed Single Storey Building at Council Building
 Client: Local Government Authority (LGA)
 Project Number: A/2023/038
 Date: 18 June 2023
 Architect: ABDUL WAHID MOHAMED
 Engineer: -
 Drawn by: ISMAIL RAFAEEL
 Services: NASHEED
 Interior: -

General Notes:

Rev no	Date
-	-
-	-
-	-


The contents of these drawings remain as a property of Arcon Private Limited. Any use other than those expressly stated is a violation of this copyright

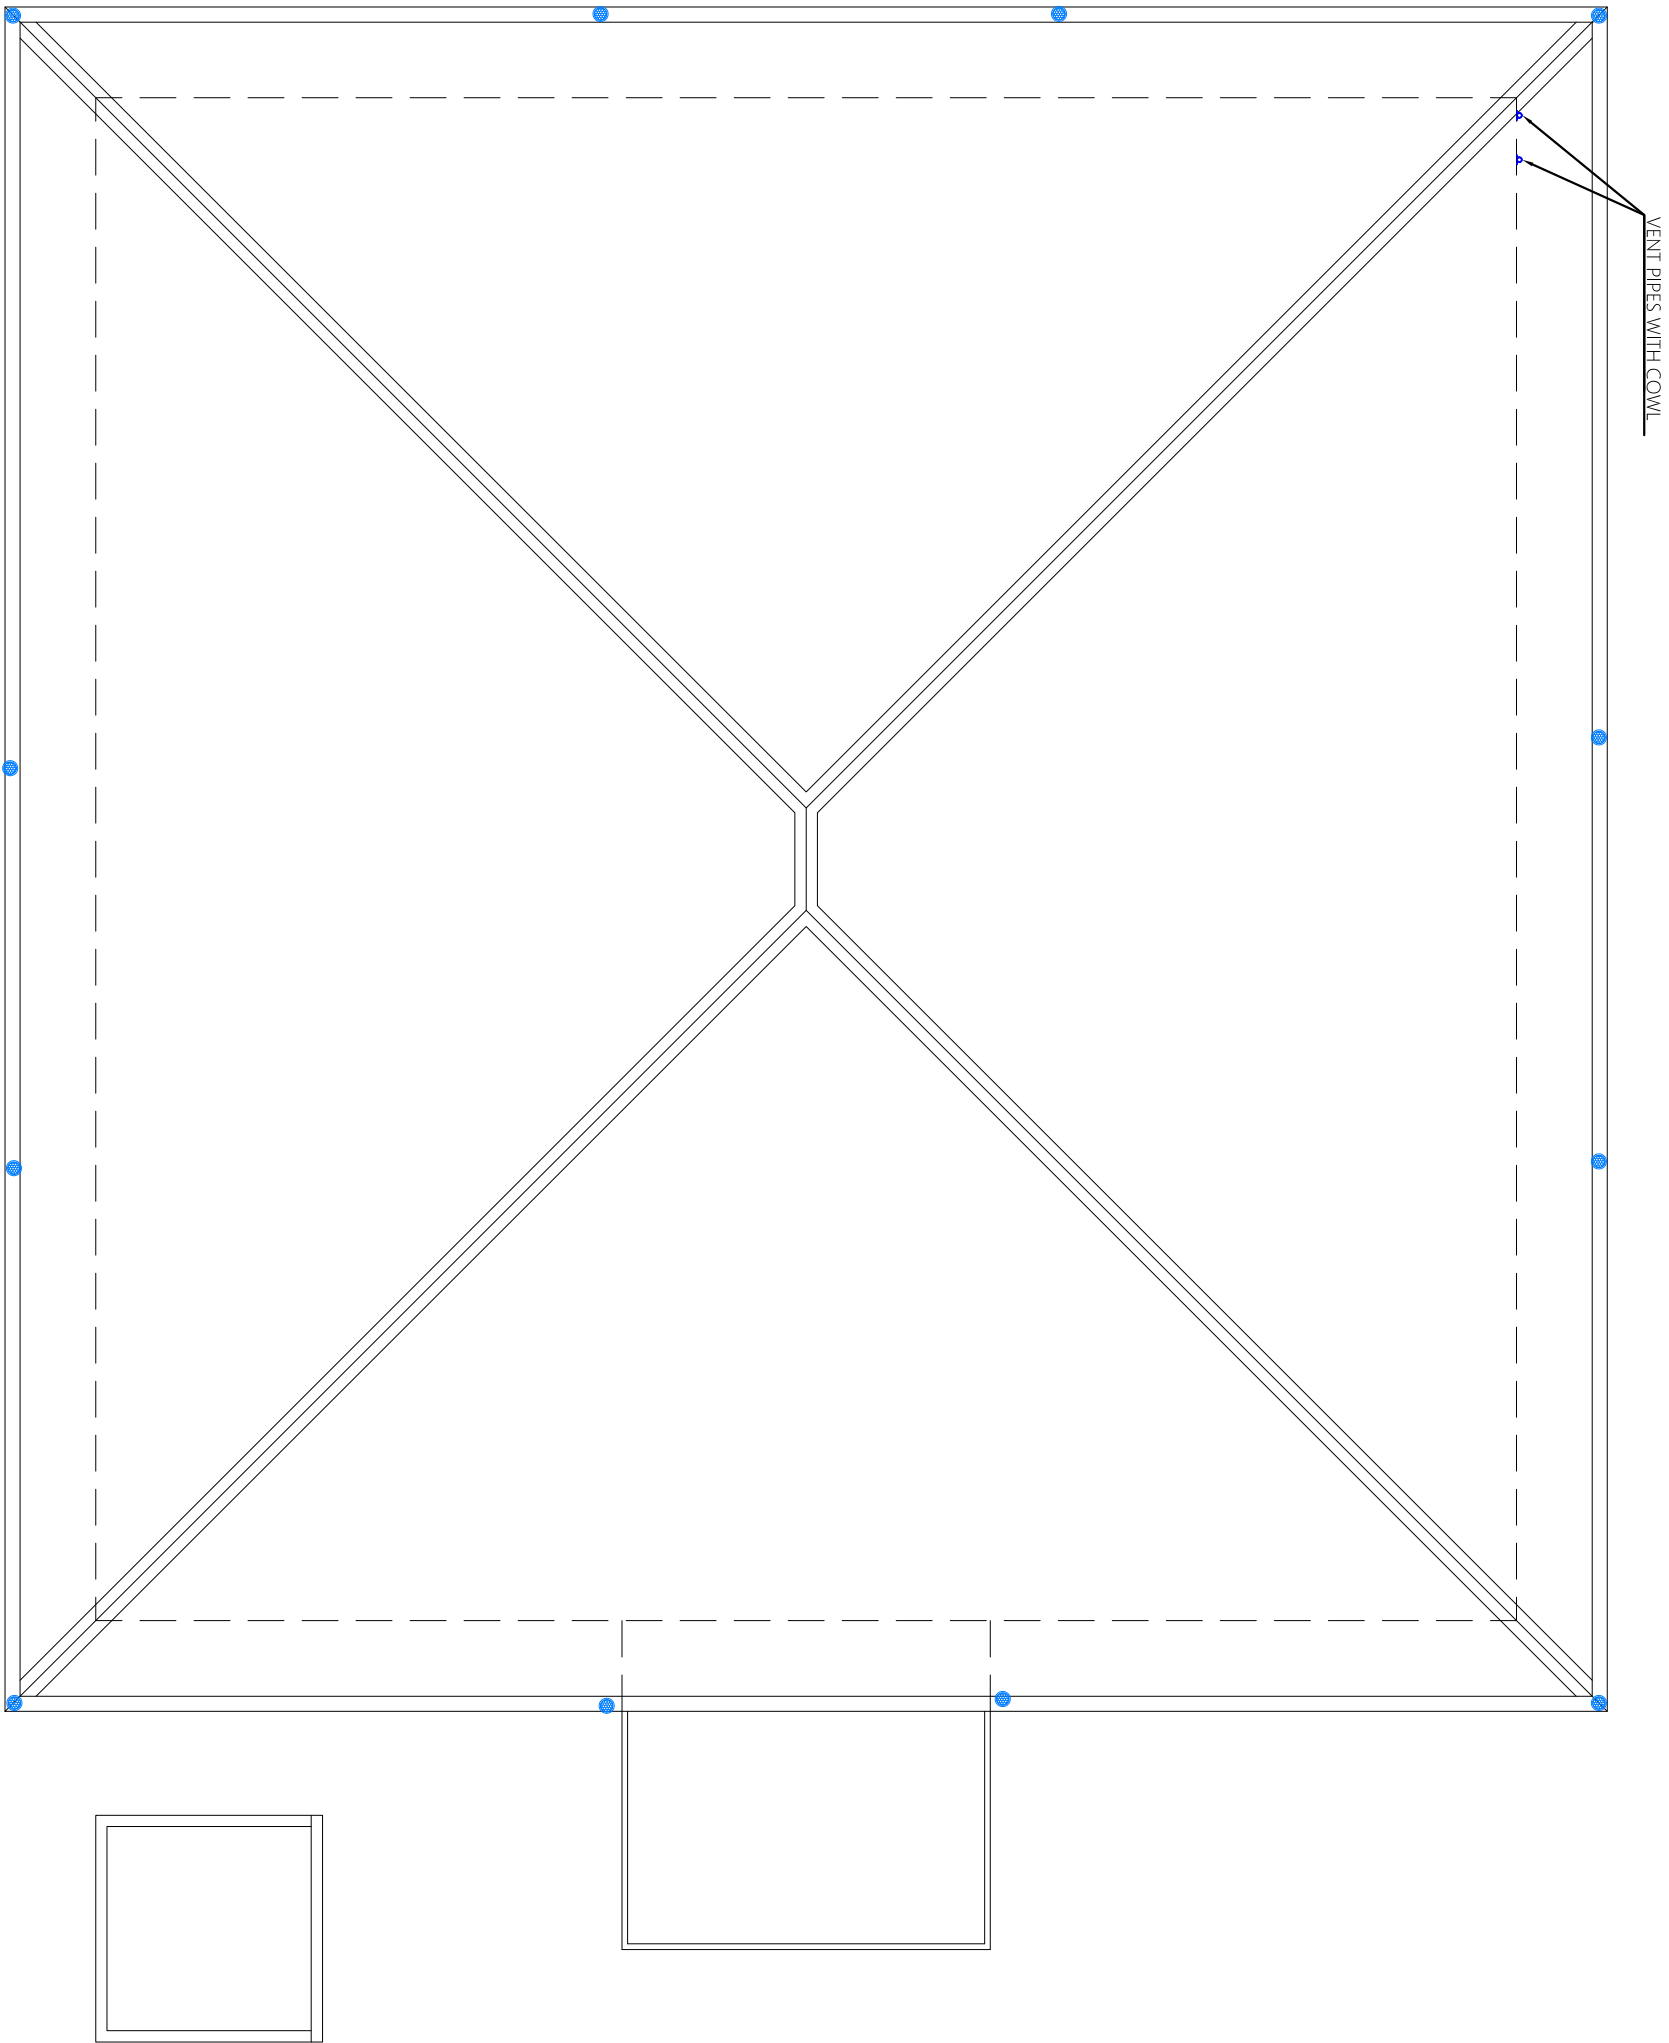

- Legend**
- Floor Drain
 - Floor Gully
 - 400 Stub For Washing Machine Or Tub
 - 820 Soil Pipe (UPVC Pipe)
 - 820 Soil Vent Pipe (UPVC Pipe)
 - 630 Waste Pipe (UPVC Pipe)
 - 630 Waste Vent Pipe (UPVC Pipe)
 - 400 Waste Pipe (UPVC Pipe)
 - 400 Manhole Vent Pipe (UPVC Pipe)
 - 110 Rain Water Pipes (UPVC Pipe)
 - Gully Trap
 - 1100 Rainwater Outlet
 - Clean Out Point
 - Bottle Trap


Notes:-

 - All Drainage Pipes Should Have At A Slope Of 1/150
- All Floor Drains Should Have "P" Traps



ROOF DRAINAGE LAYOUT

1:100

 <p>ARCON PRIVATE LIMITED T: +969320203, M: +969792023 W: www.arcon.com.lk Ground Floor, 41, Sagar Highway, Sabarimala, Negombo, Sri Lanka</p>	<p>Proposed Single Storey Building at Council Building Client: Local Government Authority (LGA) Project Number: A/2023/038 Date: 18 June 2023 Architect : ABDUL WAHID MOHAMED Engineer : - Drawn by : ISMAIL RAFAEEL Services : NASHEED Interior : -</p>	<table border="1" style="width: 100%; border-collapse: collapse;"> <thead> <tr> <th>Rev no</th> <th>Date</th> <th>General Notes:</th> </tr> </thead> <tbody> <tr> <td>-</td> <td>-</td> <td>-</td> </tr> <tr> <td>-</td> <td>-</td> <td>-</td> </tr> <tr> <td>-</td> <td>-</td> <td>-</td> </tr> </tbody> </table>	Rev no	Date	General Notes:	-	-	-	-	-	-	-	-	-	
Rev no	Date	General Notes:													
-	-	-													
-	-	-													
-	-	-													
<p>The contents of these drawings remain as a property of Arcon Private Limited. Any use other than those expressly stated is a violation of this copyright</p>															