



SME HUB
HDh. Kulhudhuffushi
Drawings
LOT-A

TABLE OF CONTENTS

REMARKS

SME Hub Site

- S0 Site plan-existing buildings (Indicating external demolitions)
- S1 Site plan -boundary walls, gates, lighting, power, DB and Low Voltage (CCTV) and Access Control
- S2 Entrance façade - cinema gate & Detail
- S3 Site plan- Mounting base for AC out door units

Will be issued
Will be issued


Walkway

- W1 Walkway details (roof and structure)

Cinema and Function Hall Building

- C0 Cinema & F Hall Building- Existing plan (indicating demolitions)
- C1 Cinema & F Hall Building- Proposed plan
- C2 Cinema & F Hall Building- Structural elements and walls
- C3 Cinema & F Hall Building - Section Drawing, Seating and Ramping
- C4 Cinema & F Hall Building- Mezzanine Floor
- C5 Cinema & F Hall Building- Ceiling plans with AC support structure
- C6 Cinema & F Hall Building - Lighting, Power, DB, sound and low voltage of Access control and CCTV
- C7 Cinema & F Hall AC and Ventilations
- C8 Cinema & F Hall Fire Indicative Drawings

Dhon Umar Kaleyfaanu magu

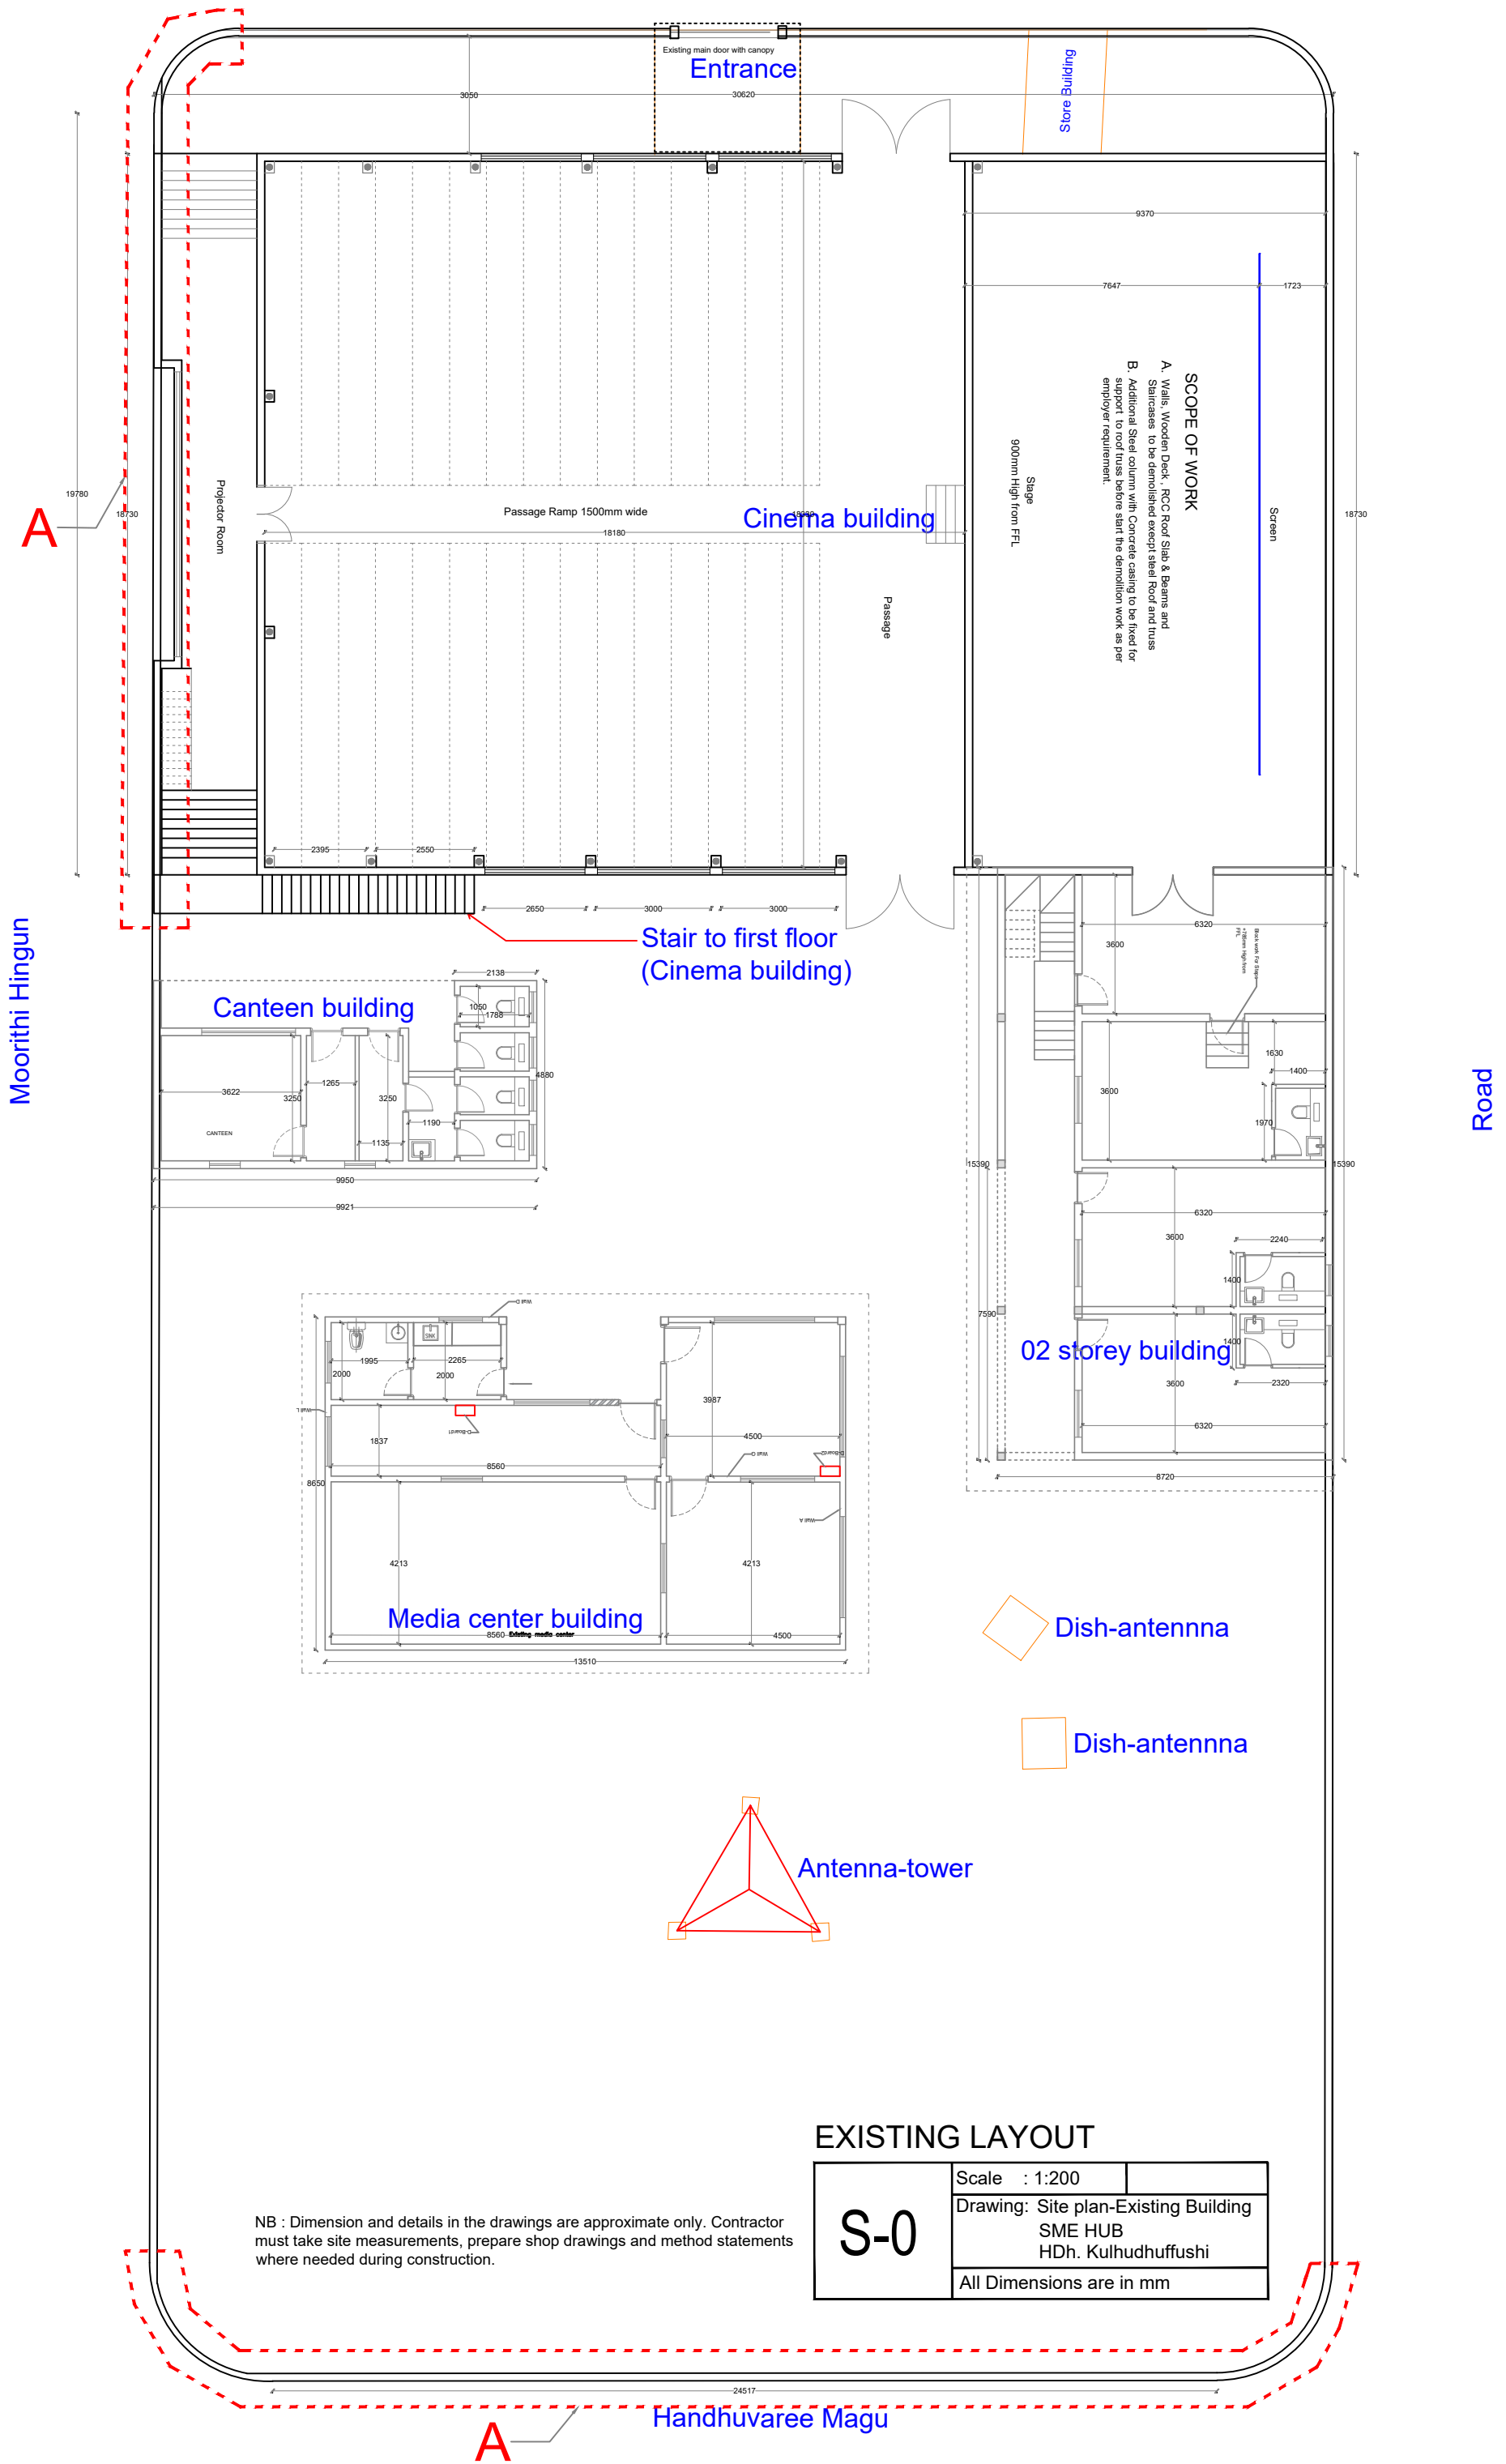

NB : Dimension and details in the drawings are approximate only. Contractor must take site measurements, prepare shop drawings and method statements where needed during construction.

EXISTING LAYOUT

S-0	Scale : 1:200
	Drawing: Site plan-Existing Building
	SME HUB
	HDh. Kulhudhuffushi
All Dimensions are in mm	

Handhuvee Magu


Moorithi Hingun

Road

A





A

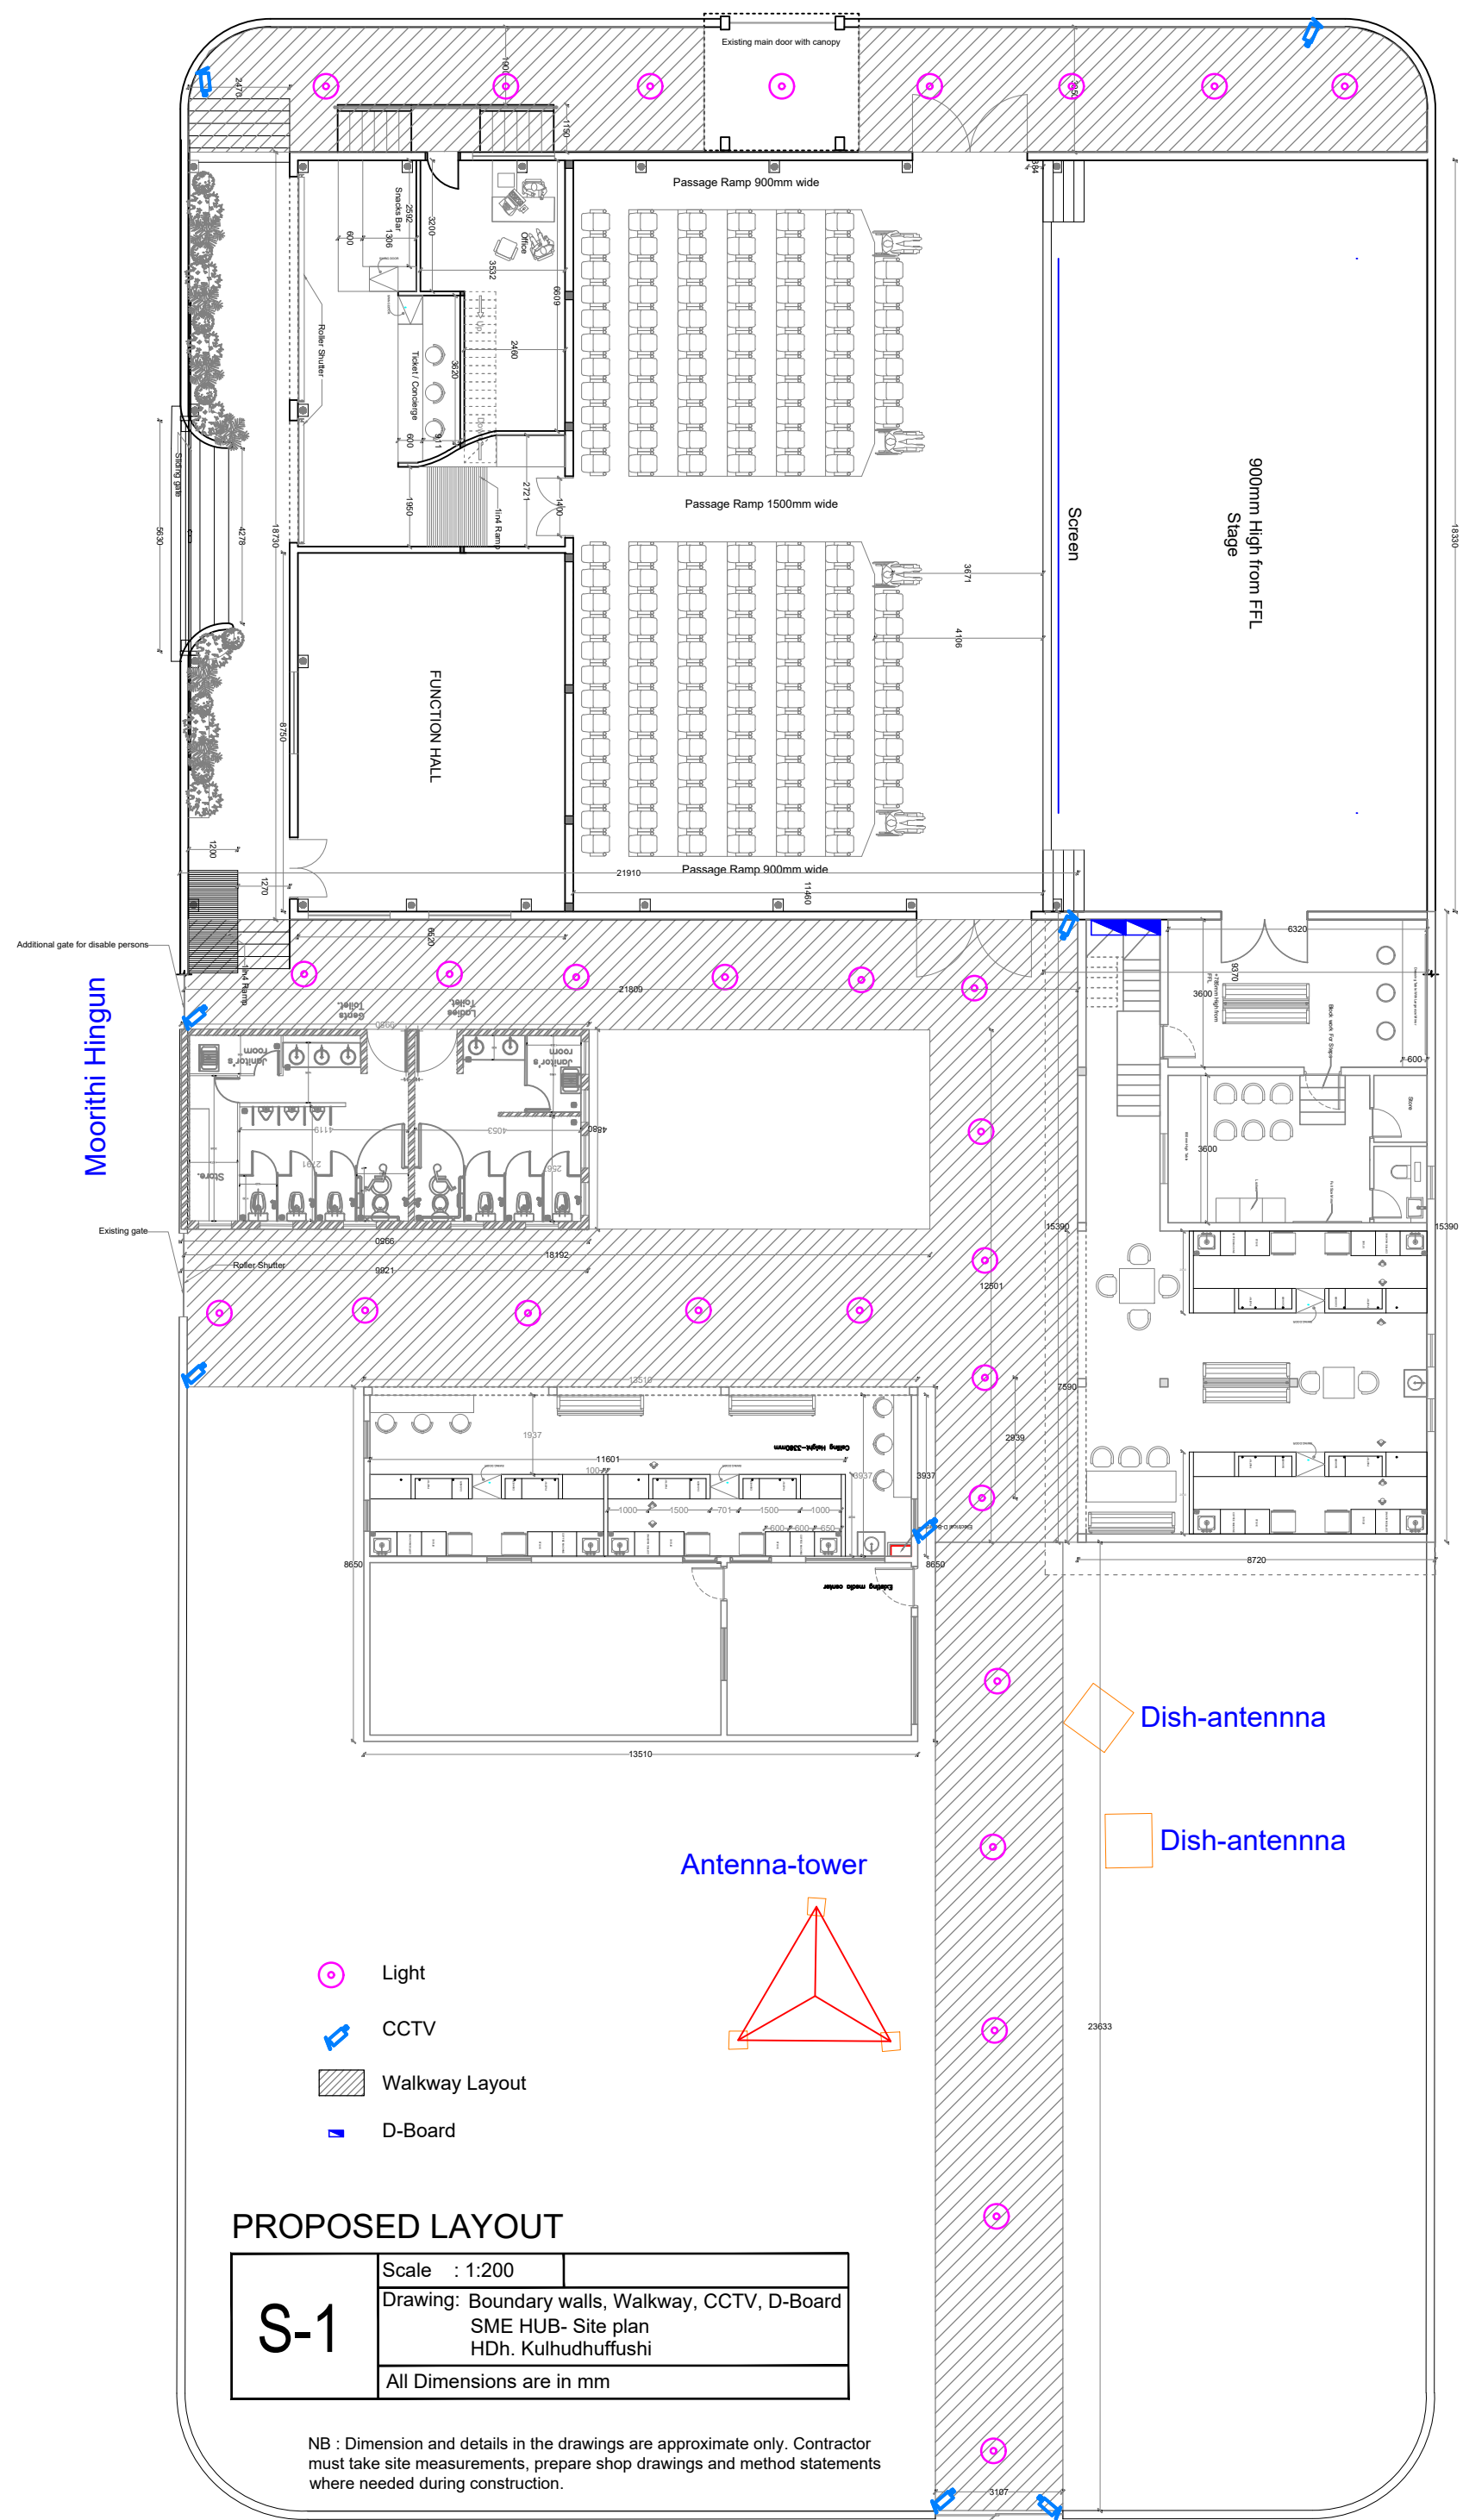Dhon Umar Kaleyfaanu magu



Moorithi Hingun

 Road


-  Light
-  CCTV
-  Walkway Layout
-  D-Board

PROPOSED LAYOUT


S-1	Scale : 1:200
	Drawing: Boundary walls, Walkway, CCTV, D-Board SME HUB- Site plan HDh. Kulhudhuffushi
	All Dimensions are in mm

NB : Dimension and details in the drawings are approximate only. Contractor must take site measurements, prepare shop drawings and method statements where needed during construction.

Handuvaree Magu

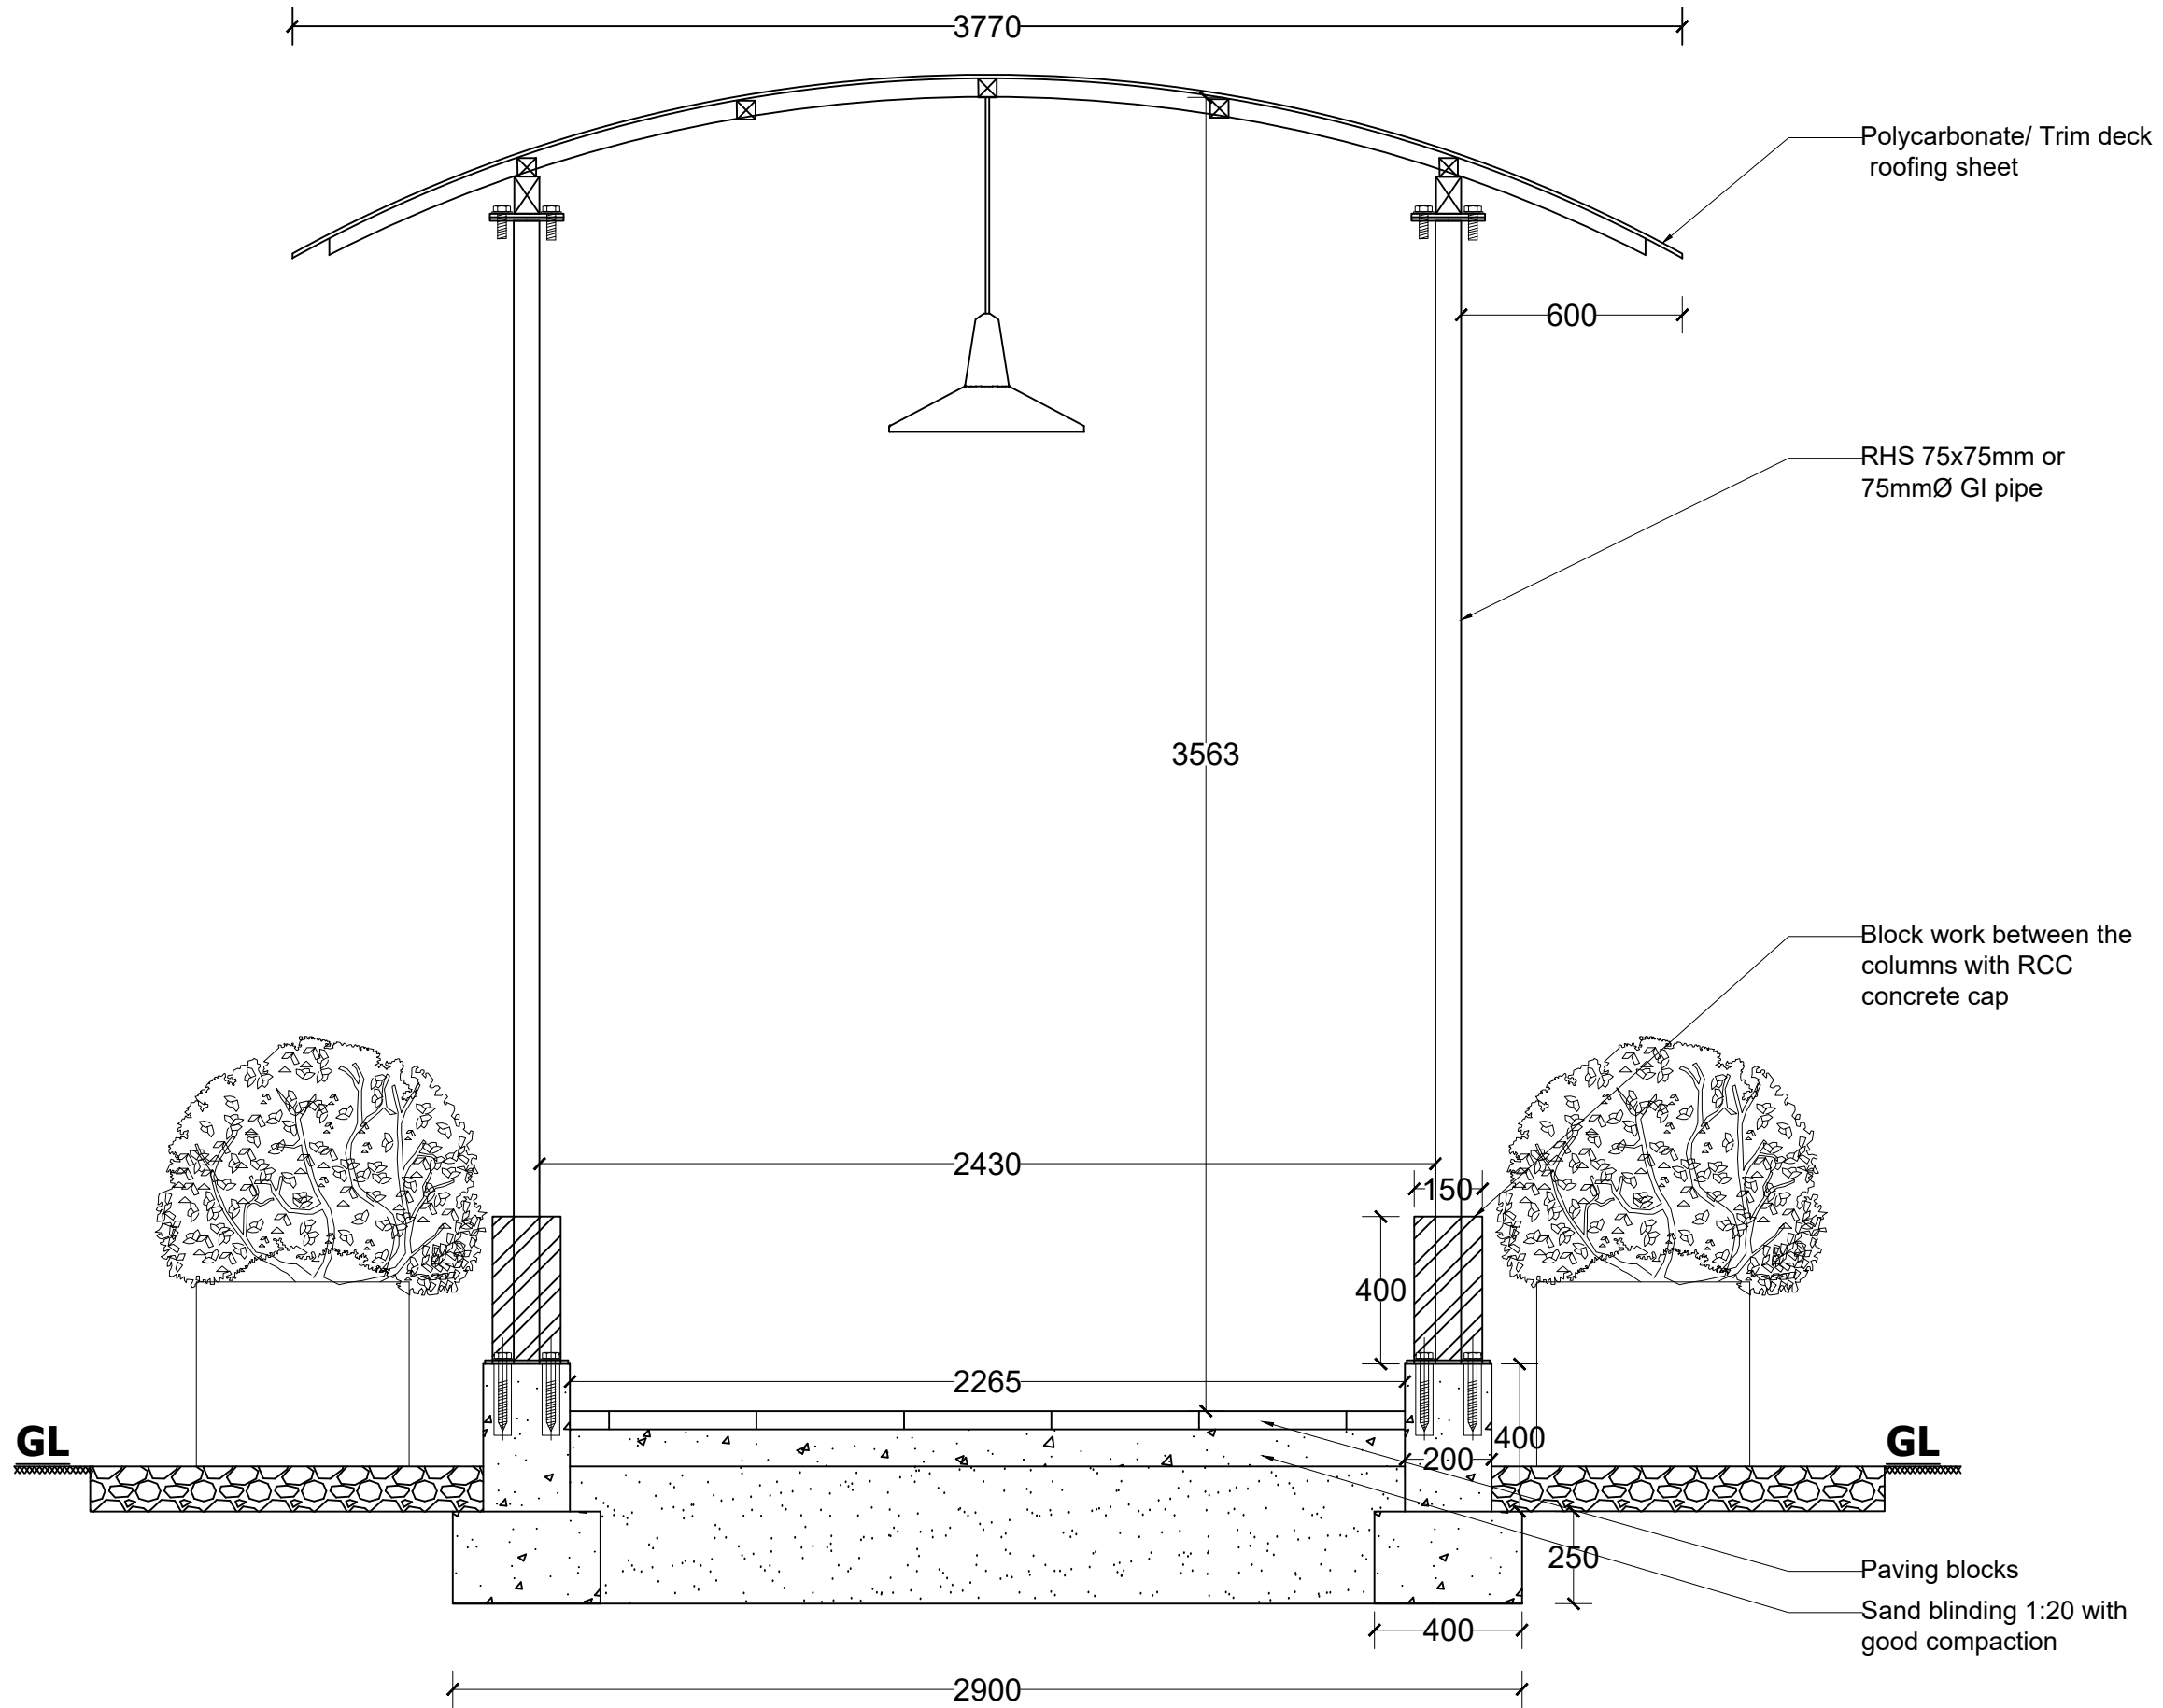


W-1	Scale : 1:40
	Drawing: Walk Way SME HUB HDh. Kulhudhuffushi
	MEDIA CENTER BUILDING
	All Dimensions are in mm

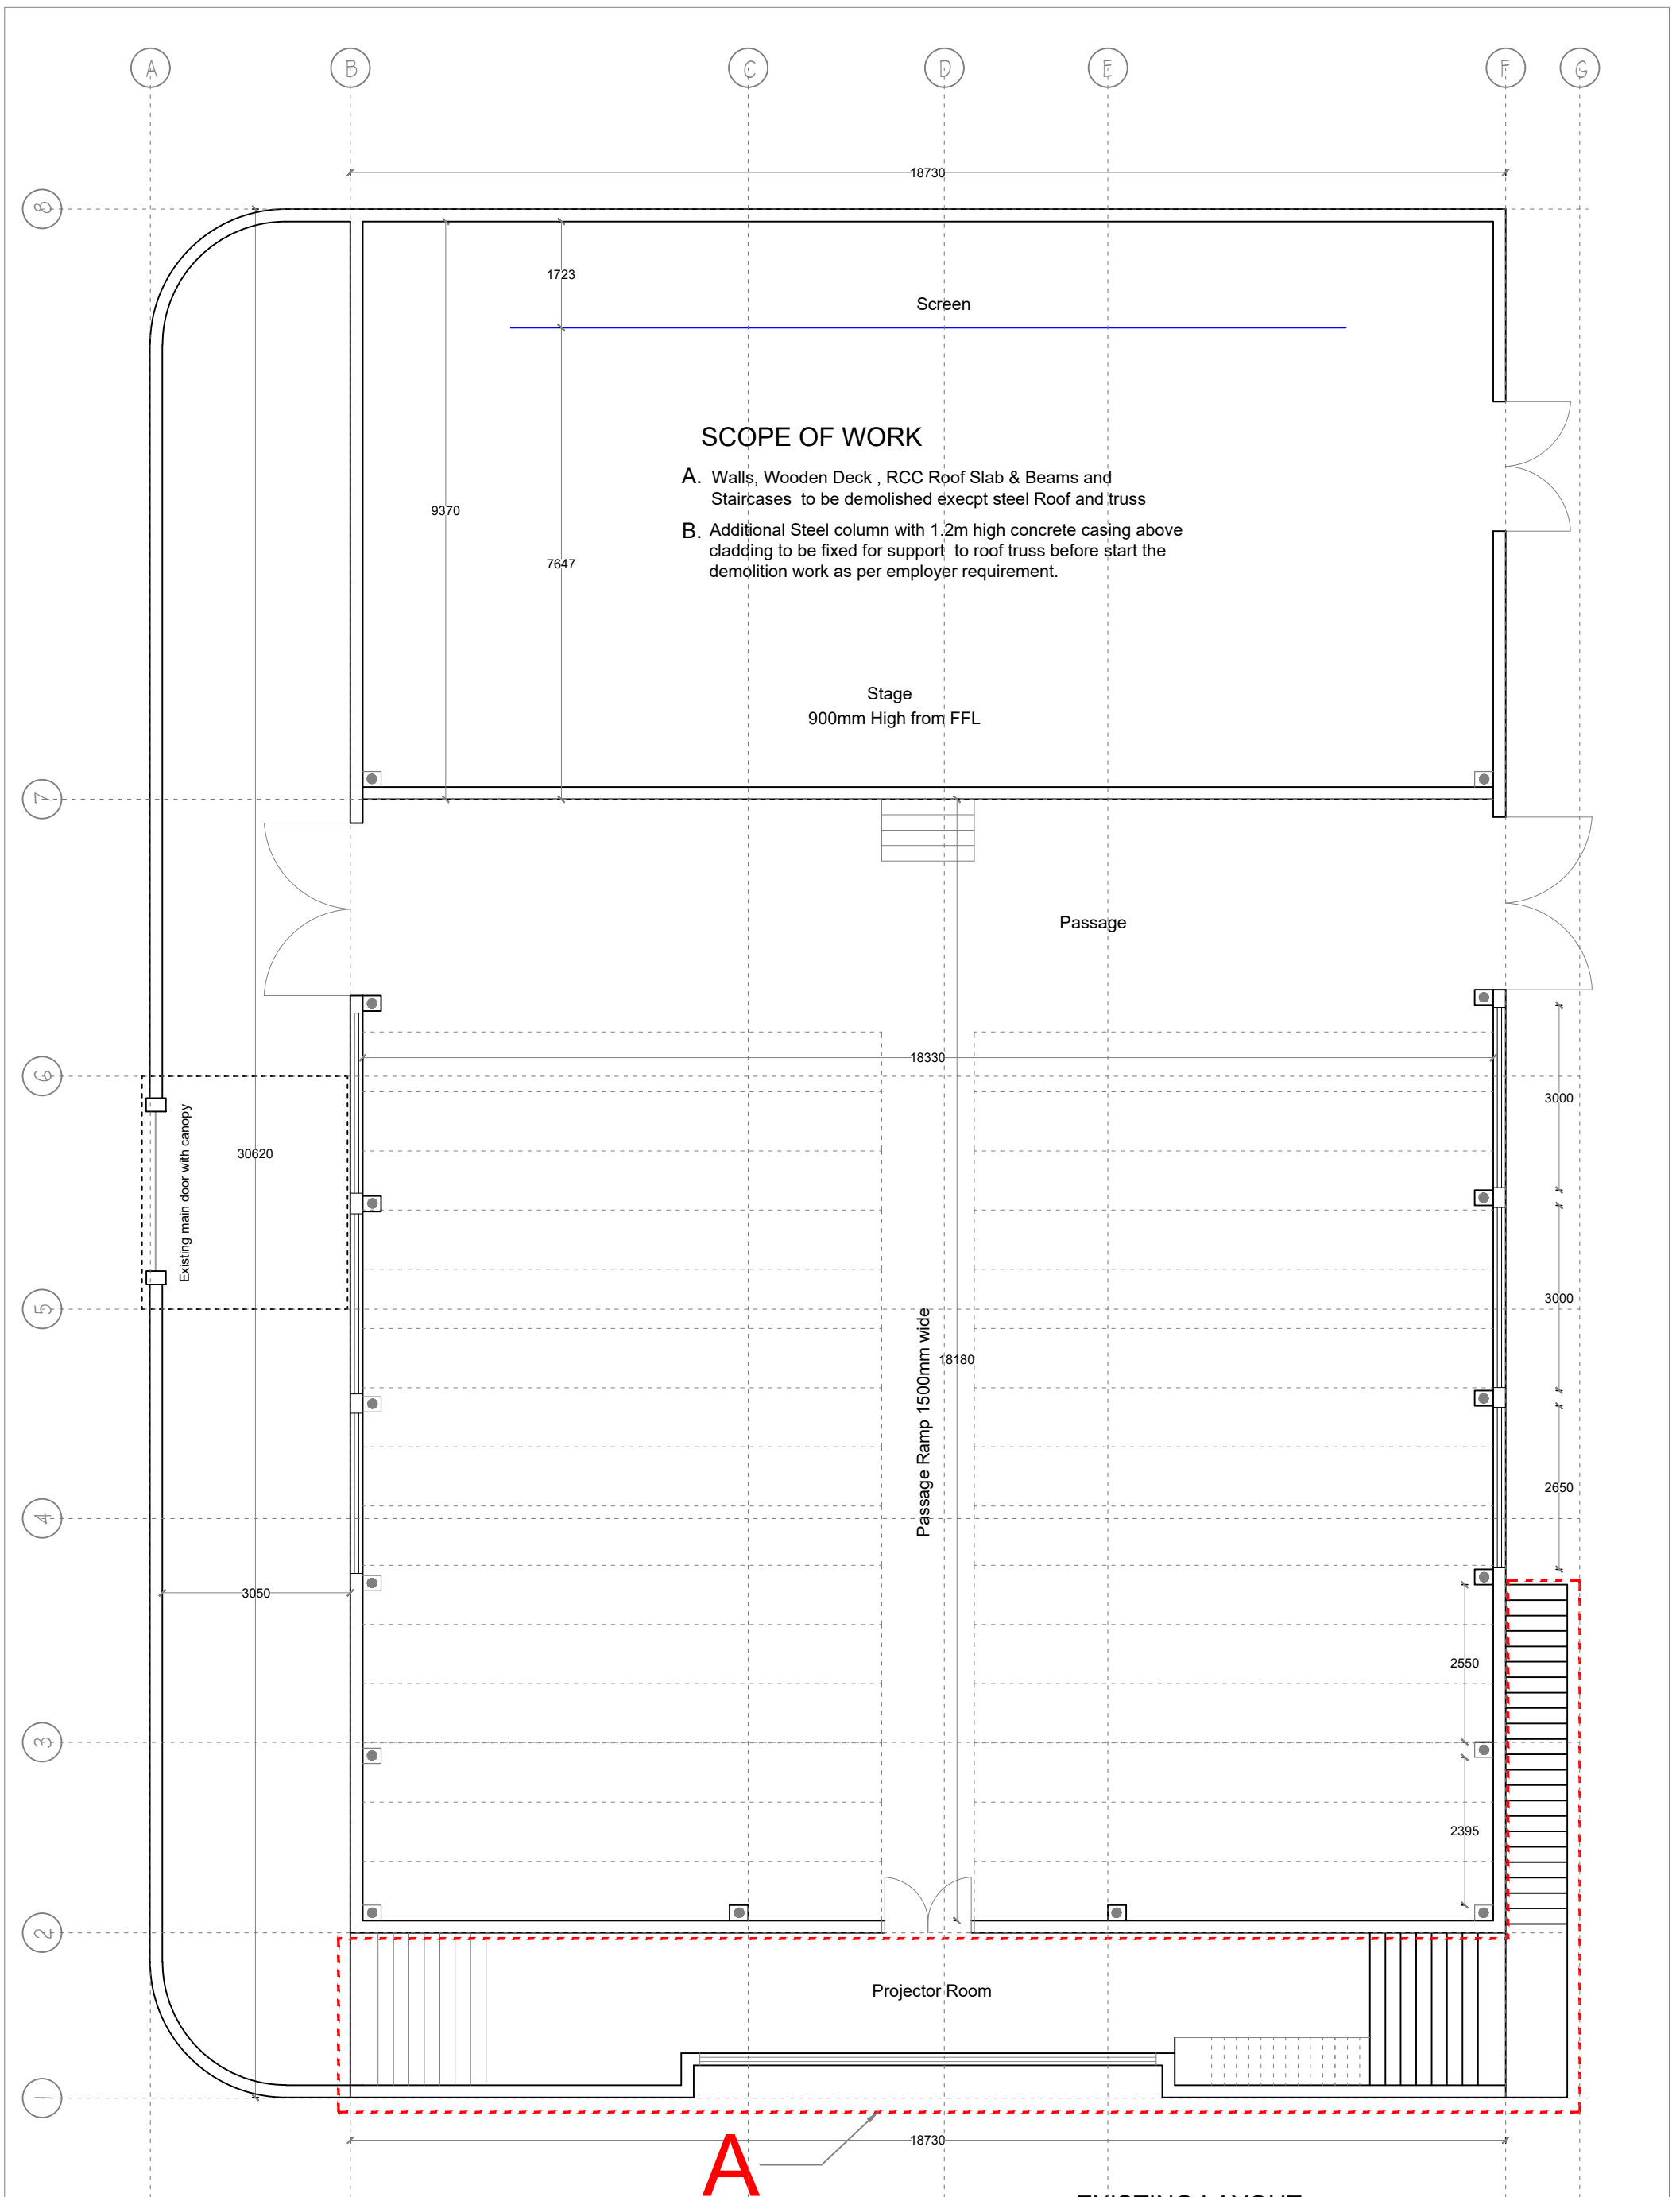

NB : Dimension and details in the drawings are approximate only. Contractor must take site measurements, prepare shop drawings and method statements where needed during construction.

EXISTING LAYOUT


C-0	Scale : 1:100
	Drawing: As built of Thiladhekunu Cinema HDh. Kulhudhuffushi
	All Dimensions are in mm

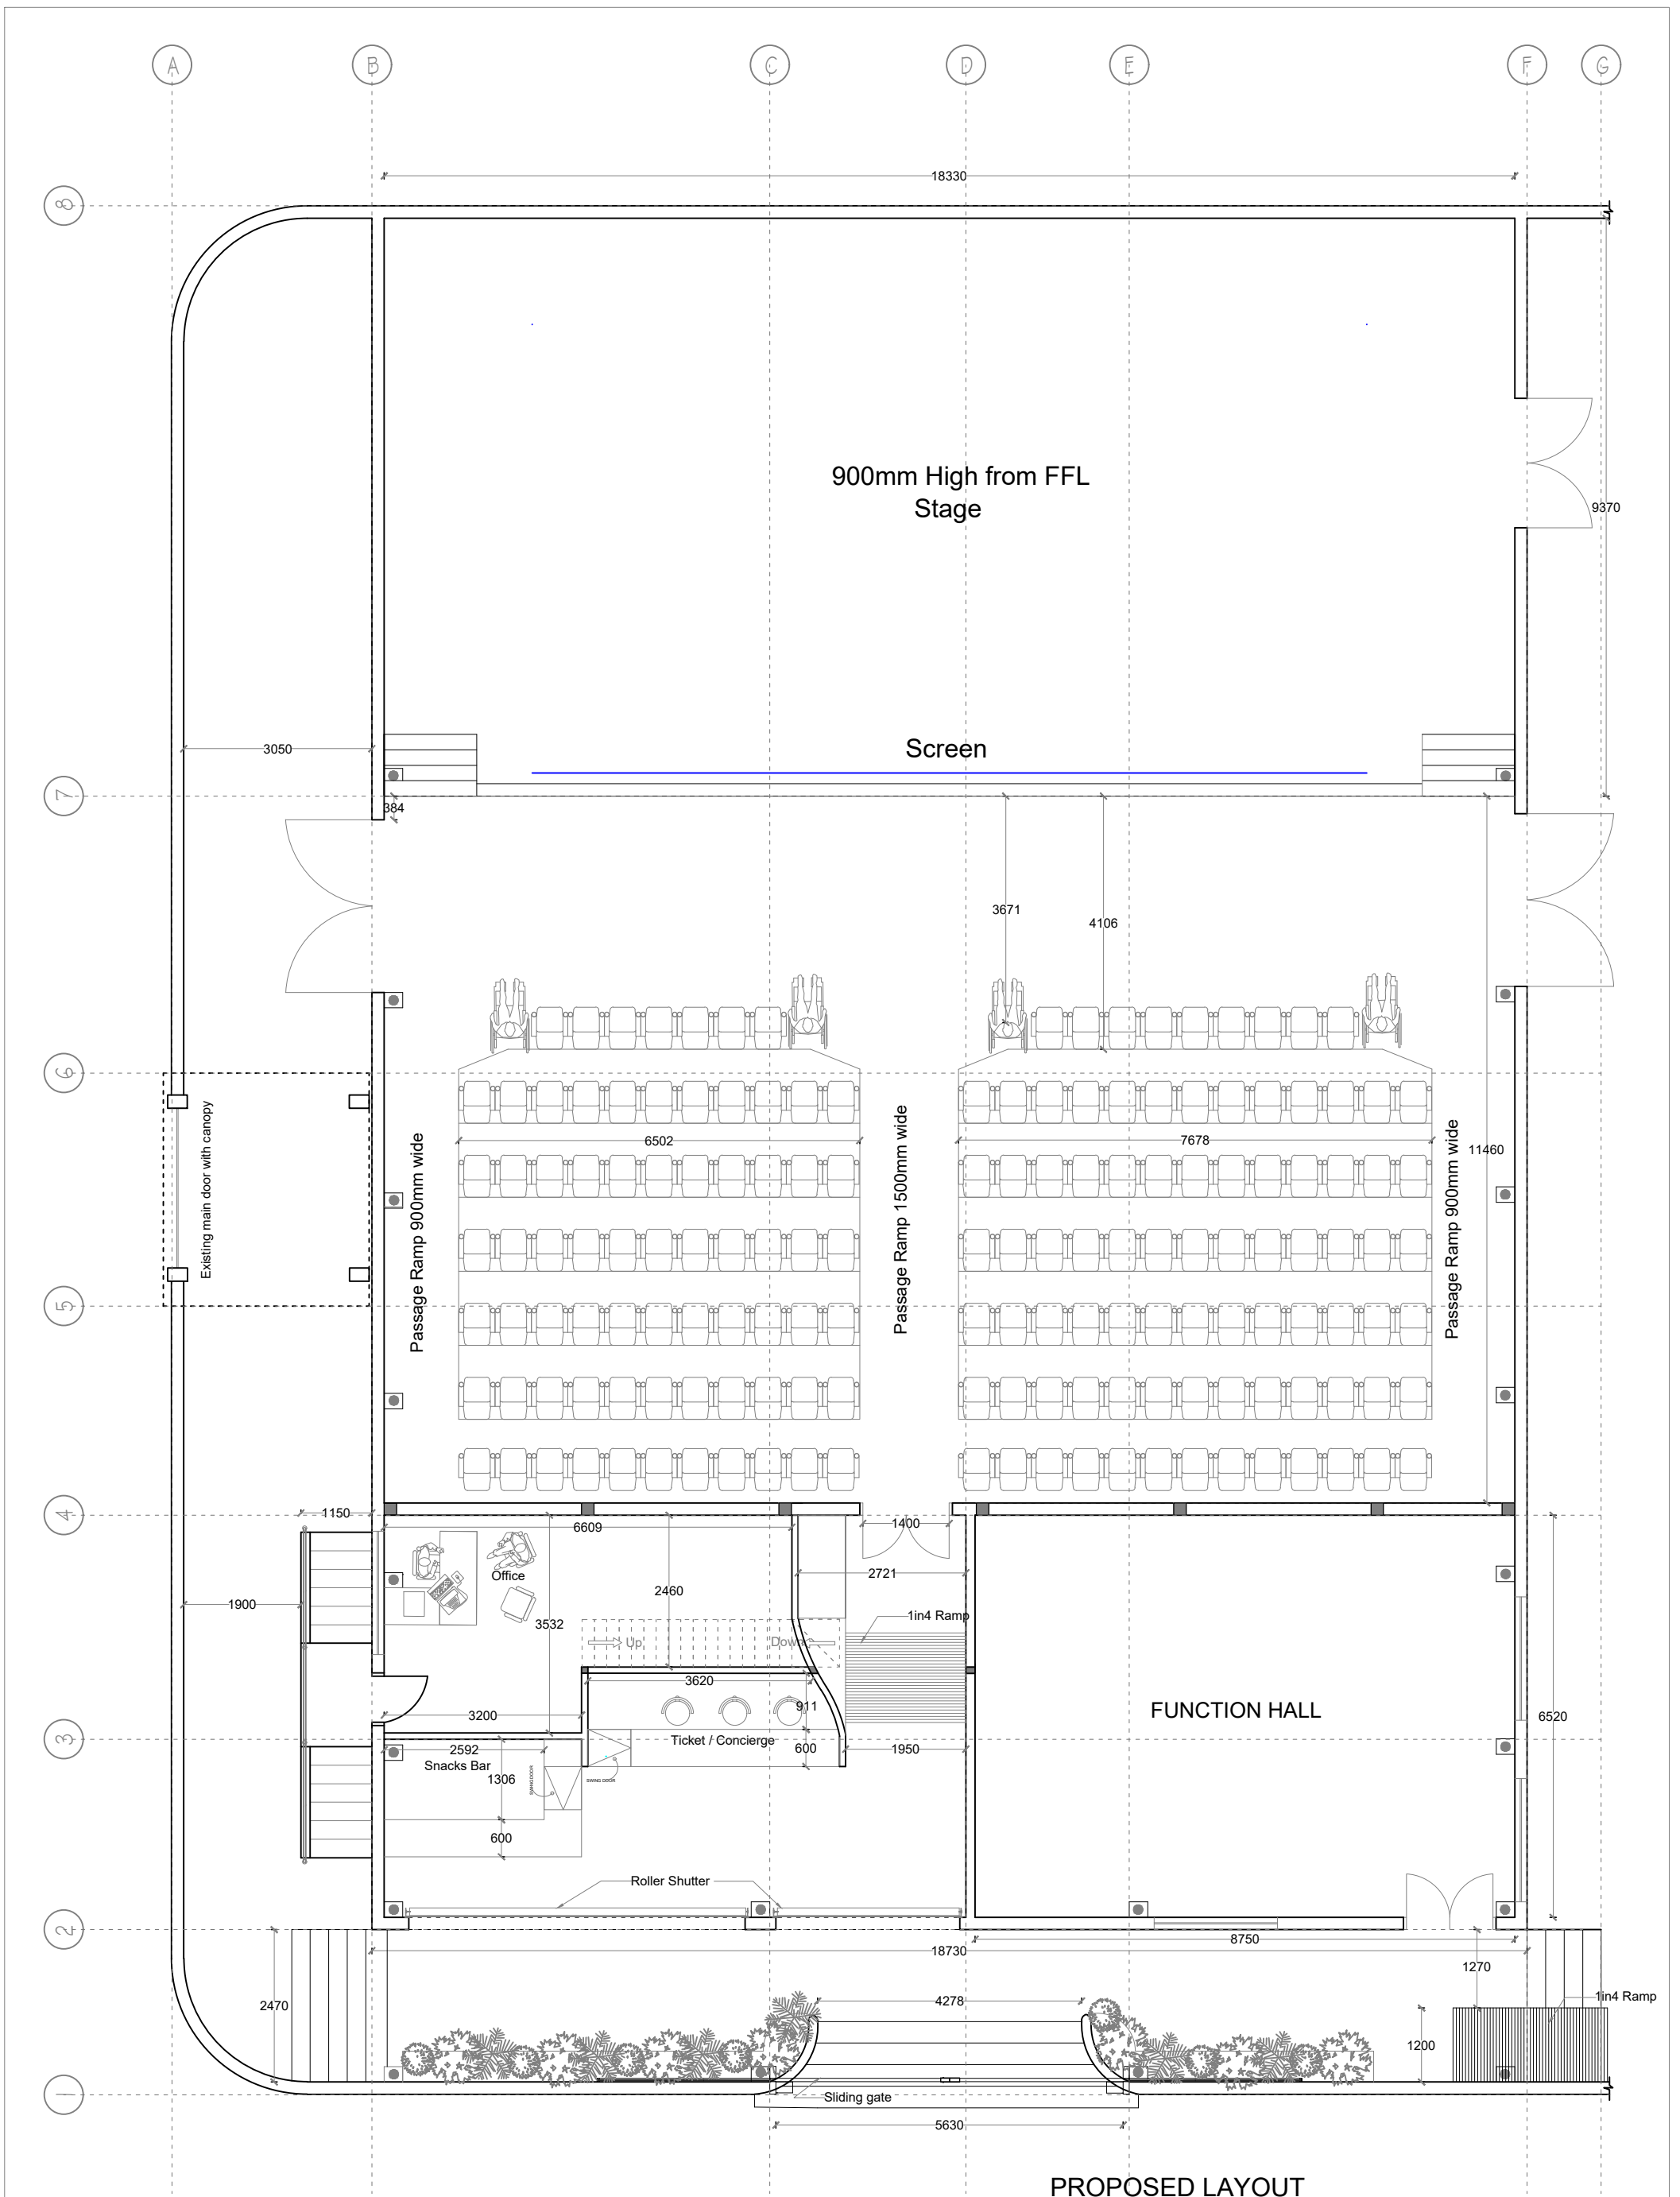

NB : Dimension and details in the drawings are approximate only. Contractor must take site measurements, prepare shop drawings and method statements where needed during construction.

PROPOSED LAYOUT


C-1	Scale : 1:100
	Drawing: Cinema-Plan
	SME HUB HDh. Kulhudhuffushi
	All Dimensions are in mm

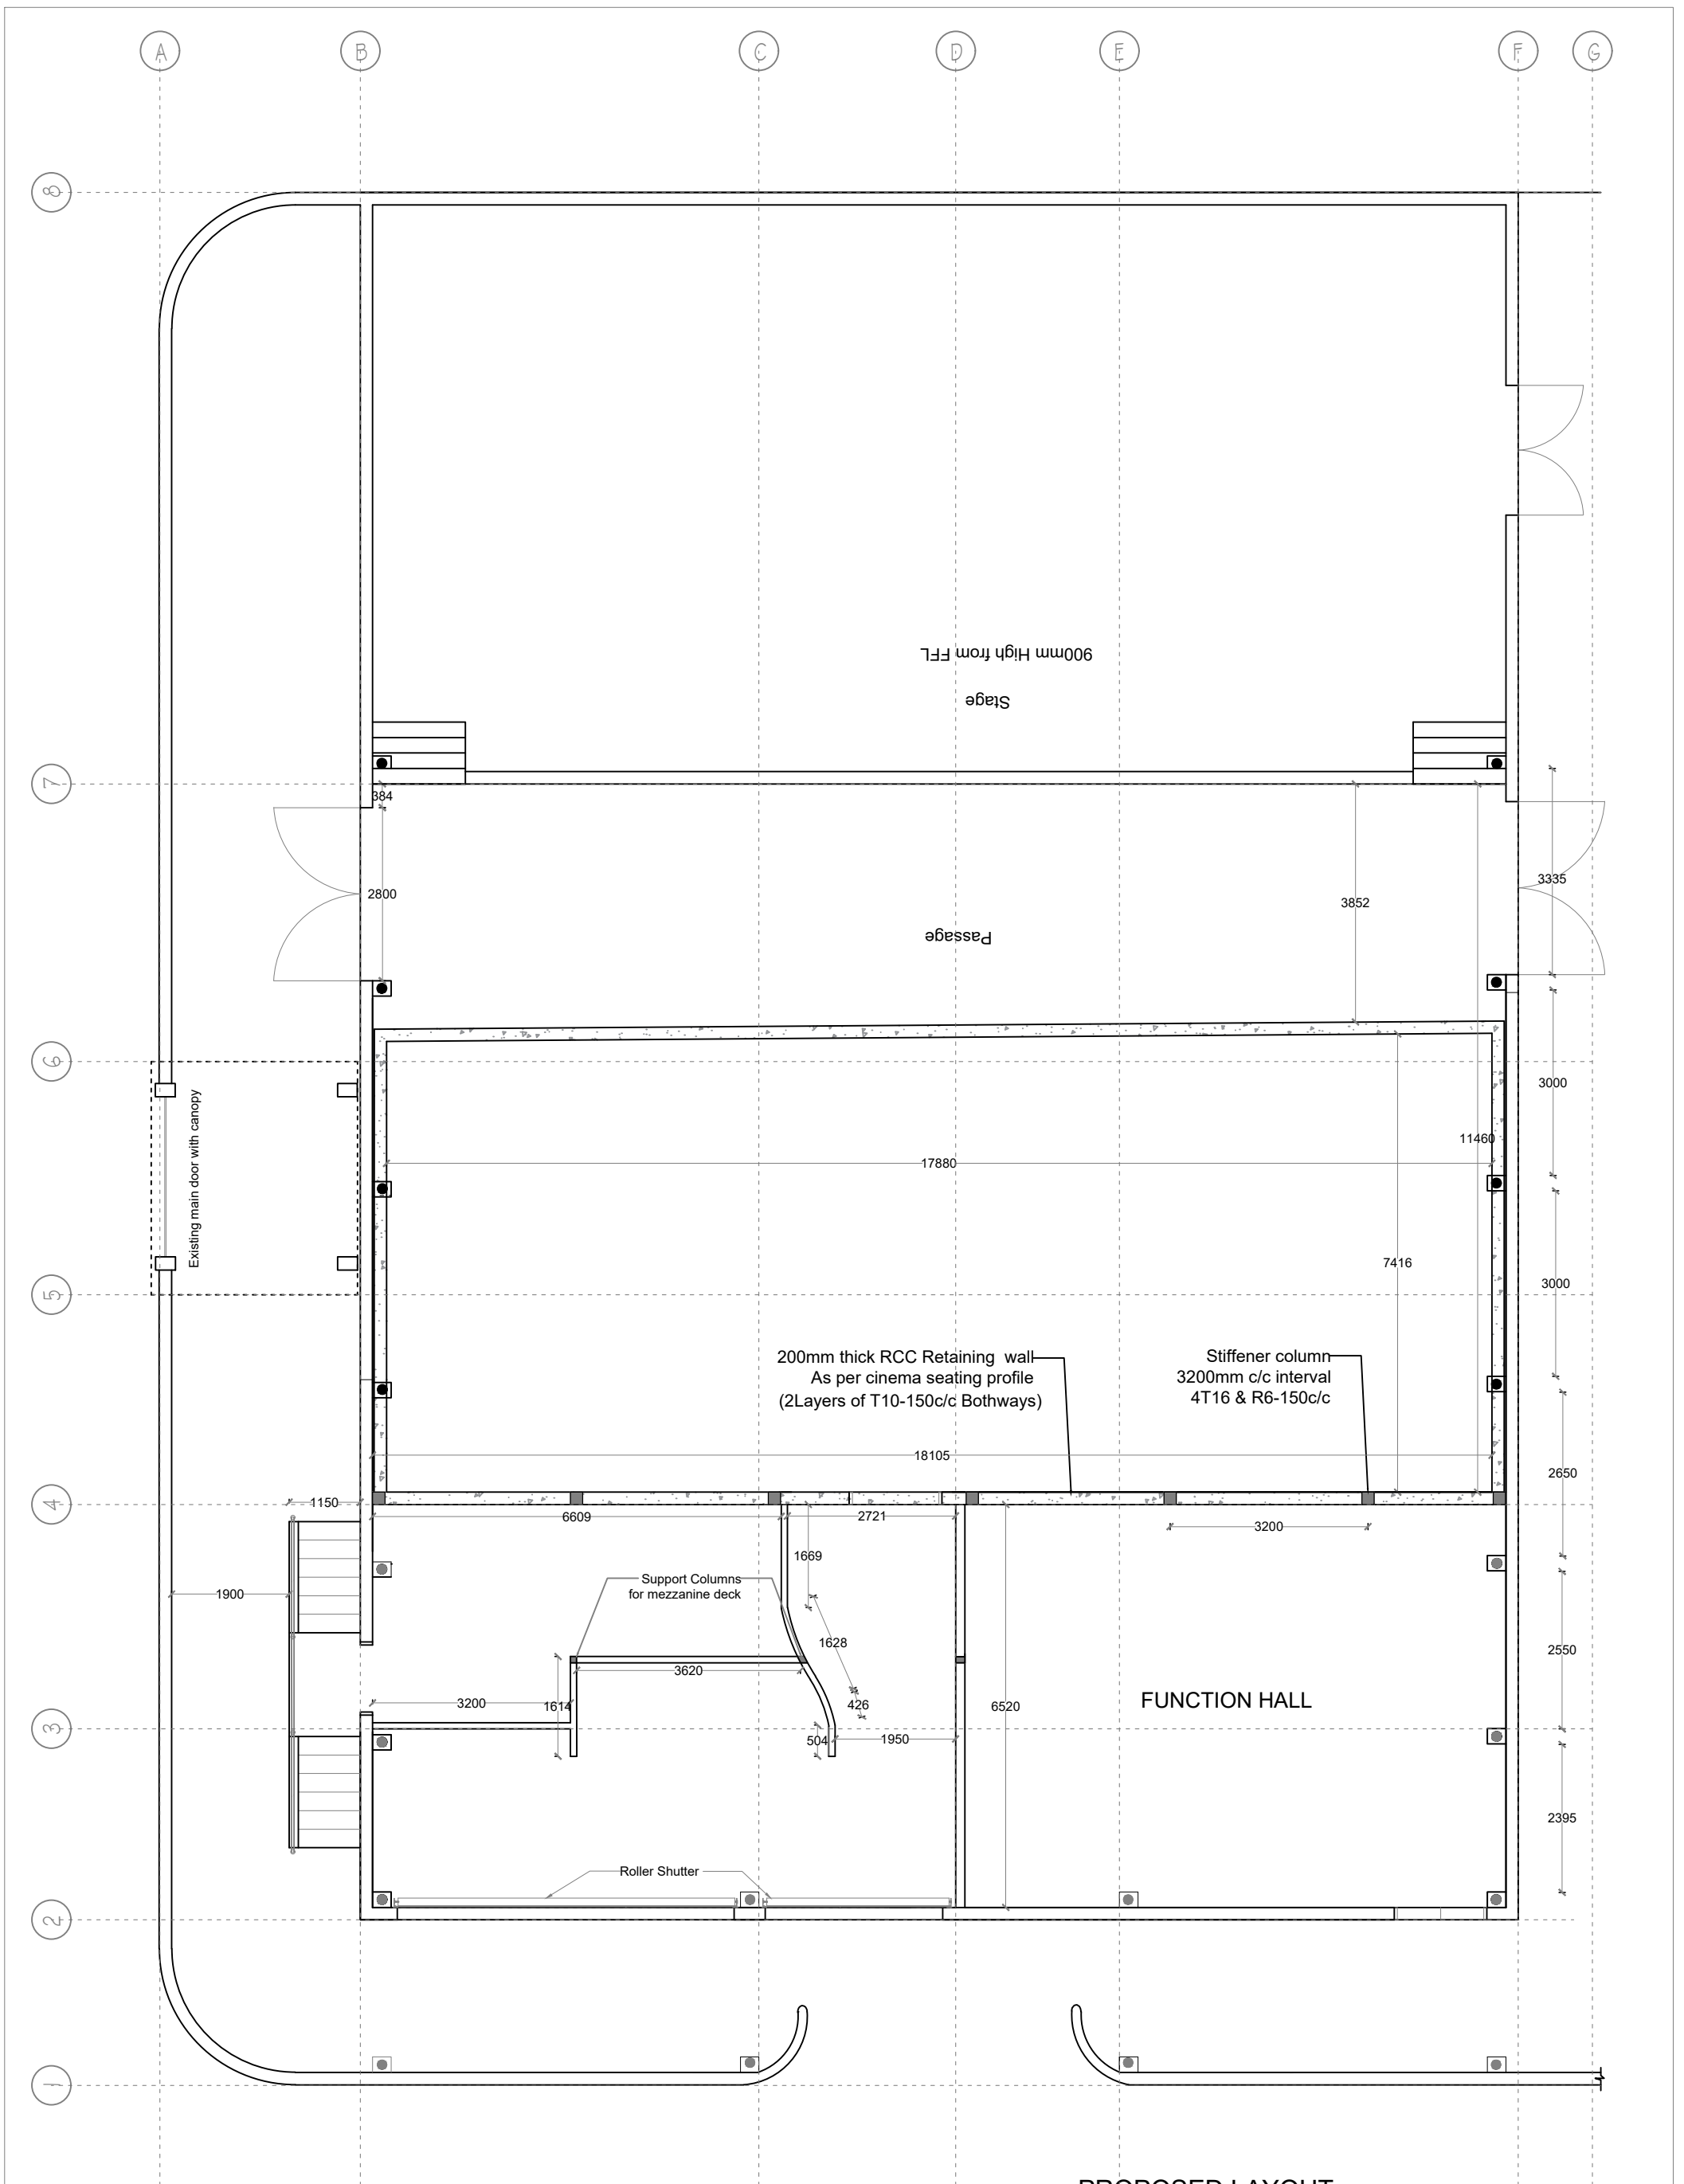

NB : Dimension and details in the drawings are approximate only. Contractor must take site measurements, prepare shop drawings and method statements where needed during construction.

PROPOSED LAYOUT


C-2	Scale : 1:100
	Drawing: Structural elements and wall
	SME HUB HDh. Kulhudhuffushi
	All Dimensions are in mm

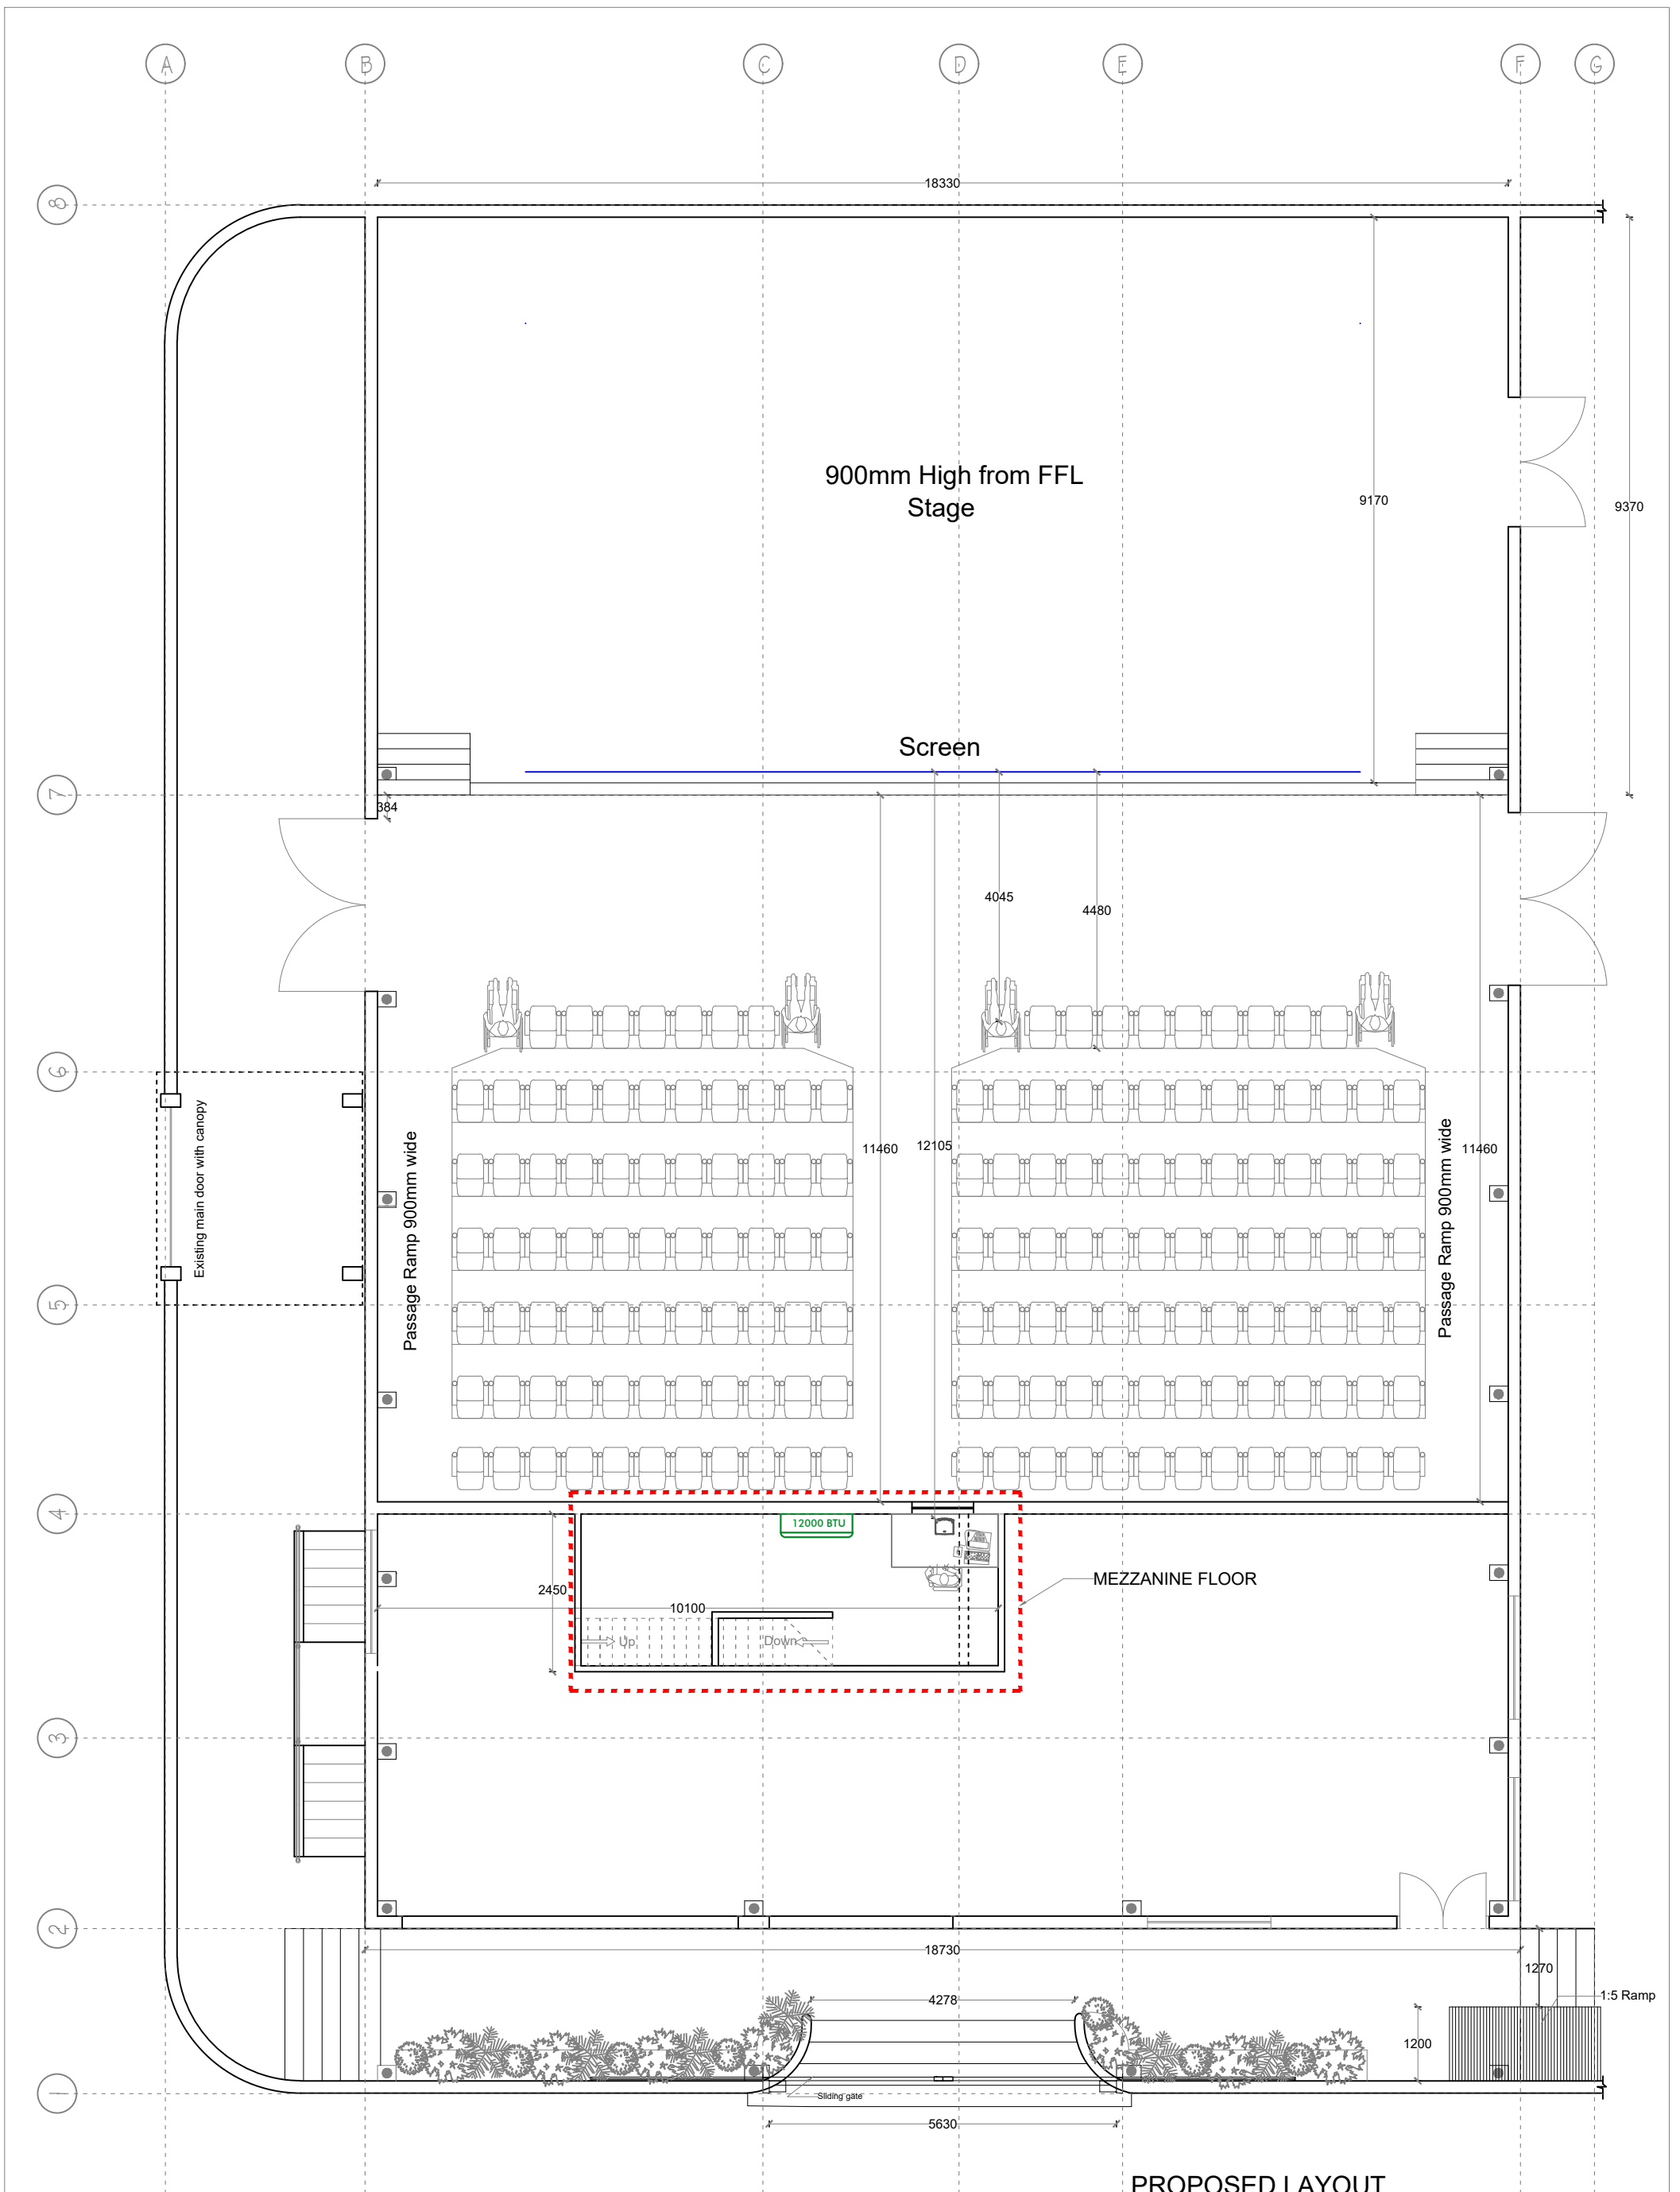

NB : Dimension and details in the drawings are approximate only. Contractor must take site measurements, prepare shop drawings and method statements where needed during construction.

PROPOSED LAYOUT

C-4	Scale : 1:100
	Drawing: Mezzanine Floor SME HUB-Cinema HDh. Kulhudhuffushi
	All Dimensions are in mm

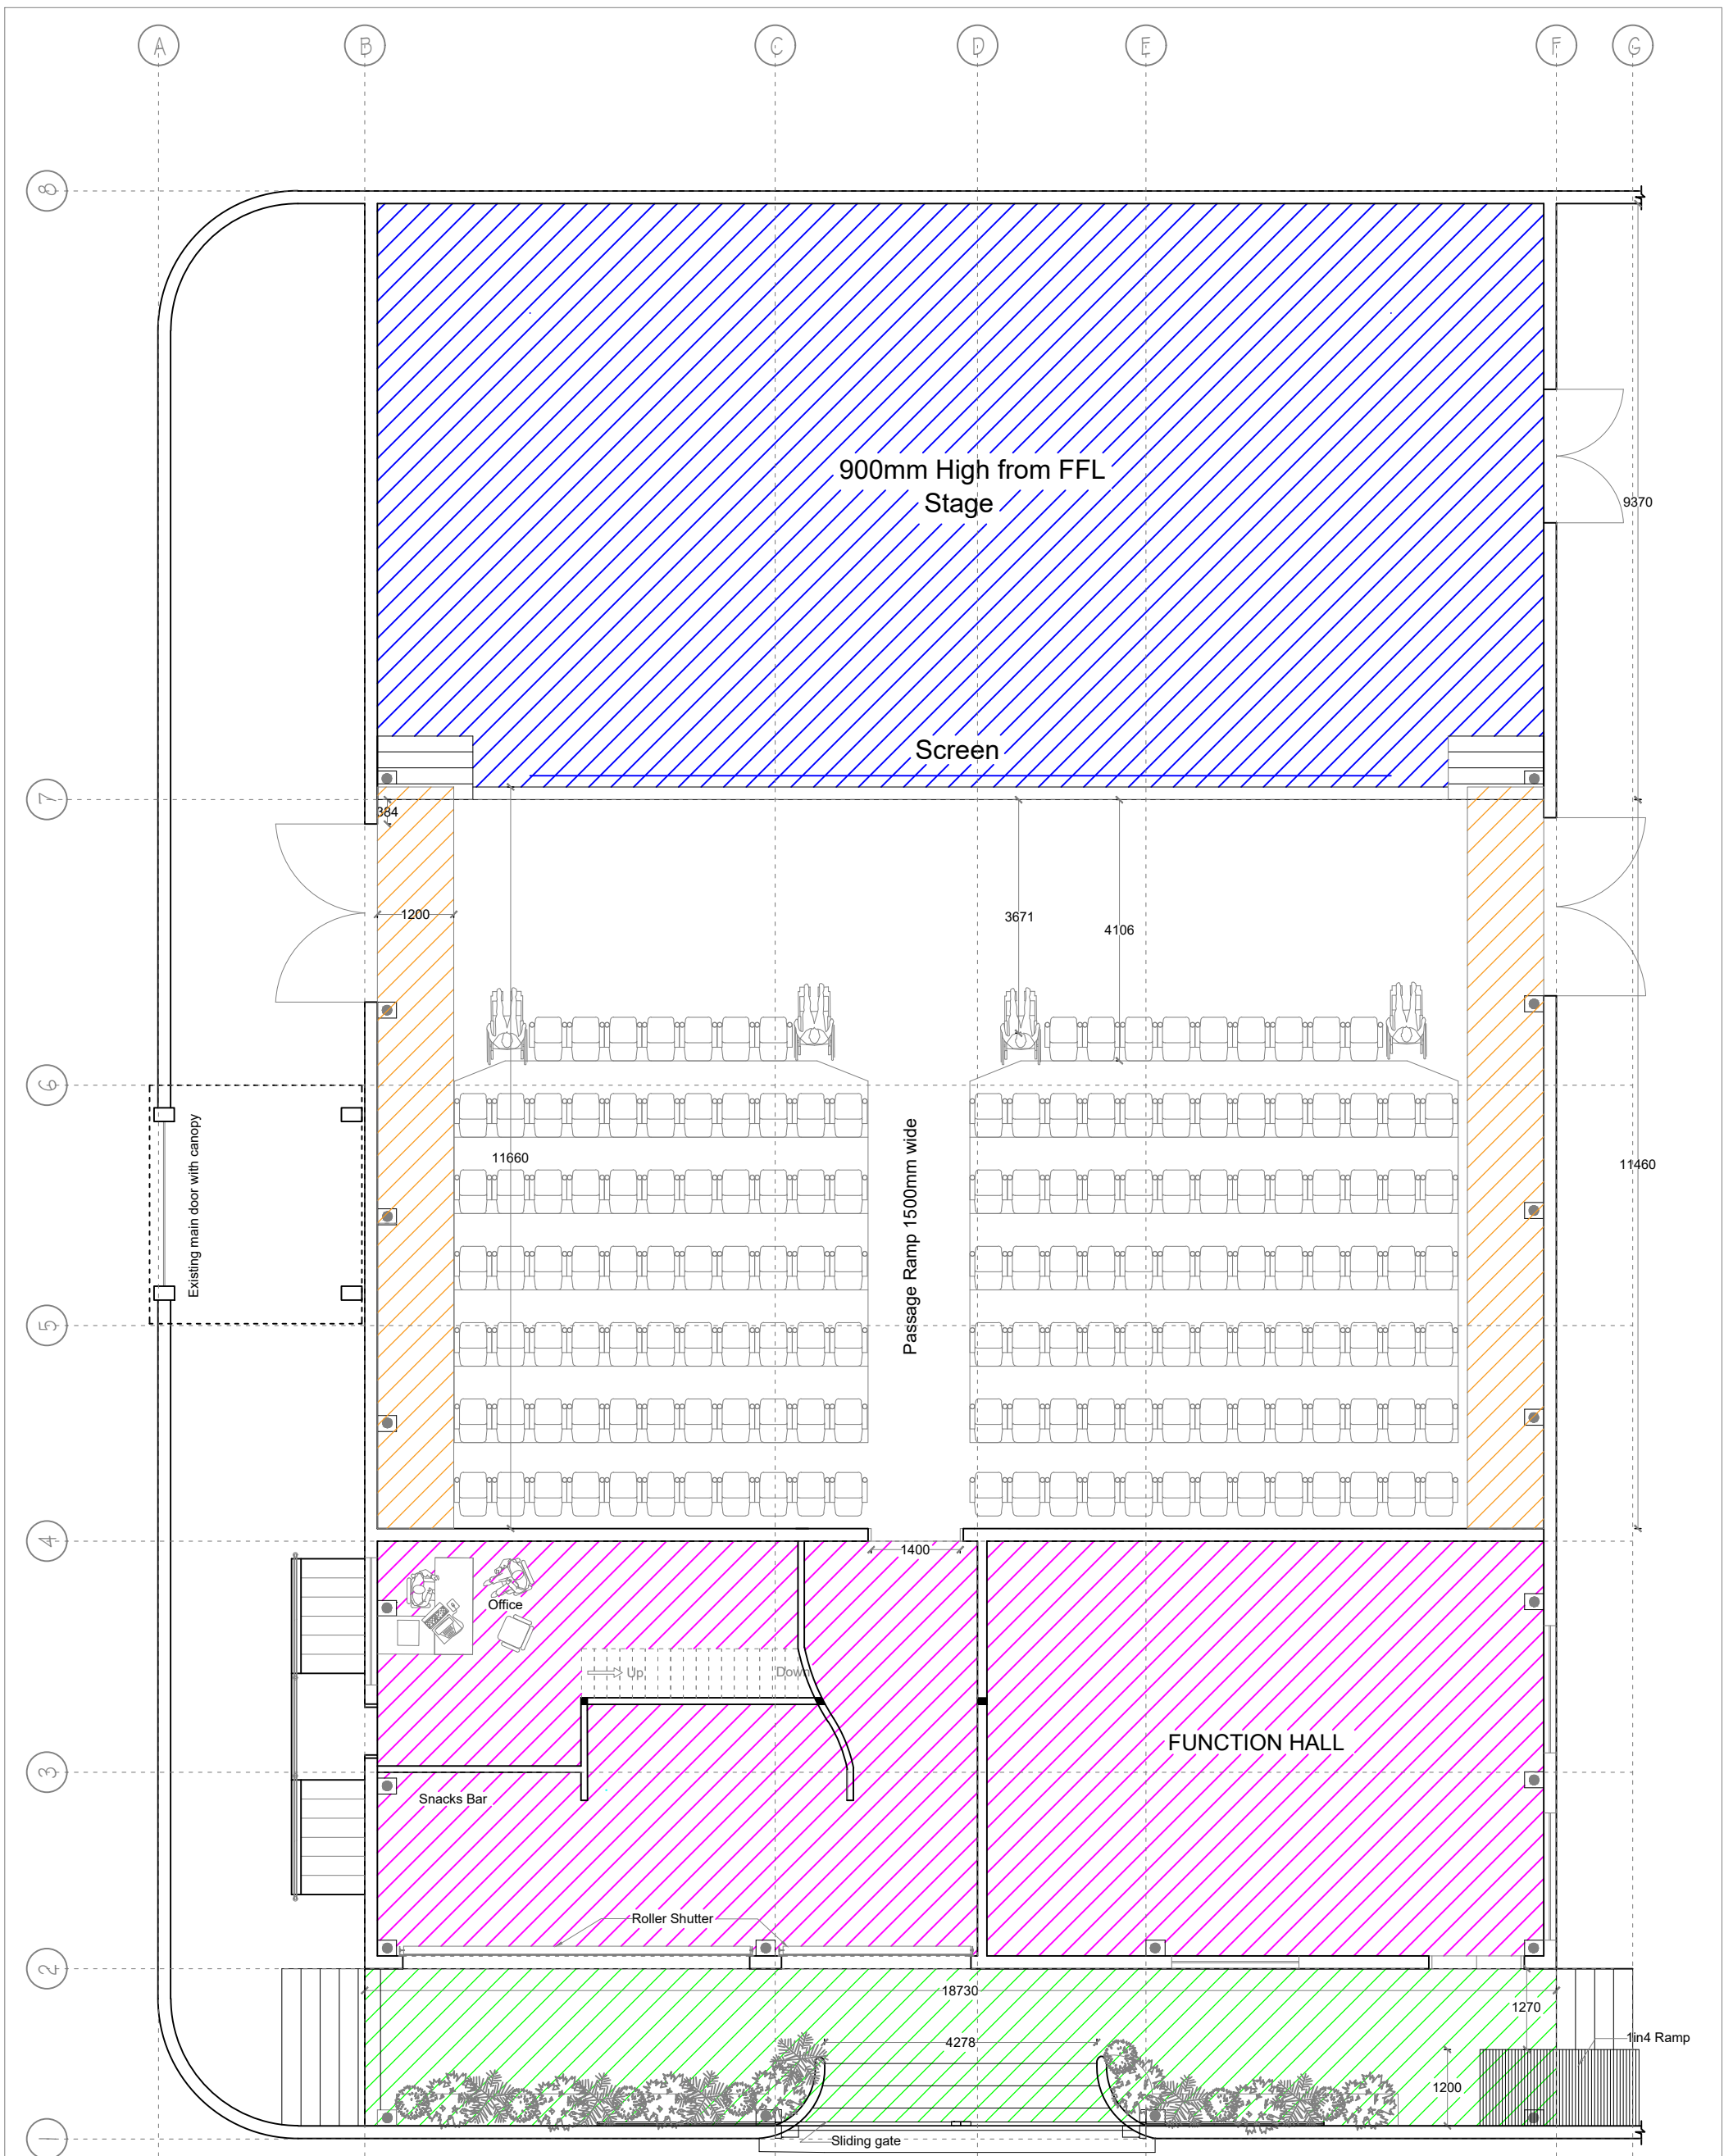

- 9m High Gypsum Board ceiling
- 3.6m High Gypsum Board ceiling
- 3.6m High Cement Board ceiling
- 5m High Cement Board ceiling

NB : Dimension and details in the drawings are approximate only. Contractor must take site measurements, prepare shop drawings and method statements where needed during construction.

PROPOSED LAYOUT

C-5	Scale : 1:100
	Drawing: Ceiling plan SME HUB- Cinema HDh. Kulhudhuffushi
	All Dimensions are in mm



LEGEND :

	13Amp POWER POINT (SINGLE)
	13Amp POWER POINT (DOUBLE)
	13Amp POWER POINT (TWIN) WITH USB CONNECTION
	15Amp POWER POINT (SINGLE)
	TV POINT
	TELEPHONE POINT
	INTERCOM
	DATA POINT (CAT 5e UTP)
	13Amp POWER POINT SINGLE (WEATHERPROOF)
	13Amp POWER POINT DOUBLE (WEATHERPROOF)
	16Amp POWER POINT SINGLE (UNIVERSAL WEATHERPROOF)
	16Amp POWER POINT SINGLE (UNIVERSAL)
	EXHAUST FAN
	DATA DISTRIBUTION BOARD
	DISTRIBUTION BOARD
	WALL LIGHT
	TUBE LIGHT
	CEILING DOWN LIGHT
	WALL MOUNT UPDOWN LIGHT
	SPOTLIGHT
	CEILING FAN
	HANGING LIGHT ON TRACK
	STRIP LIGHT
	SIGN LIGHT
	1 GANG 1 WAY SWITCH (SINGLE)
	2 GANG 1 WAY SWITCH (DOUBLE)
	1 GANG 2 WAY SWITCH (SINGLE)
	HEATER CONTROL DP SWITCH


HEIGHT OF THE FIXTURES From FFL to (mm)

A	450
B	650
C	1200
D	1385
E	1500
F	2300
G	900
H	1400
I	1800
J	2200
K	SLAB SOFFIT

NB : Dimension and details in the drawings are approximate only. Contractor must take site measurements, prepare shop drawings and method statements where needed during construction.

PROPOSED LAYOUT- CINEMA


C-6	Scale : 1:100
	Drawing: Lighting, Power & Data
	SME HUB- Ground Floor
	HDh. Kulhudhuffushi
All Dimensions are in mm	

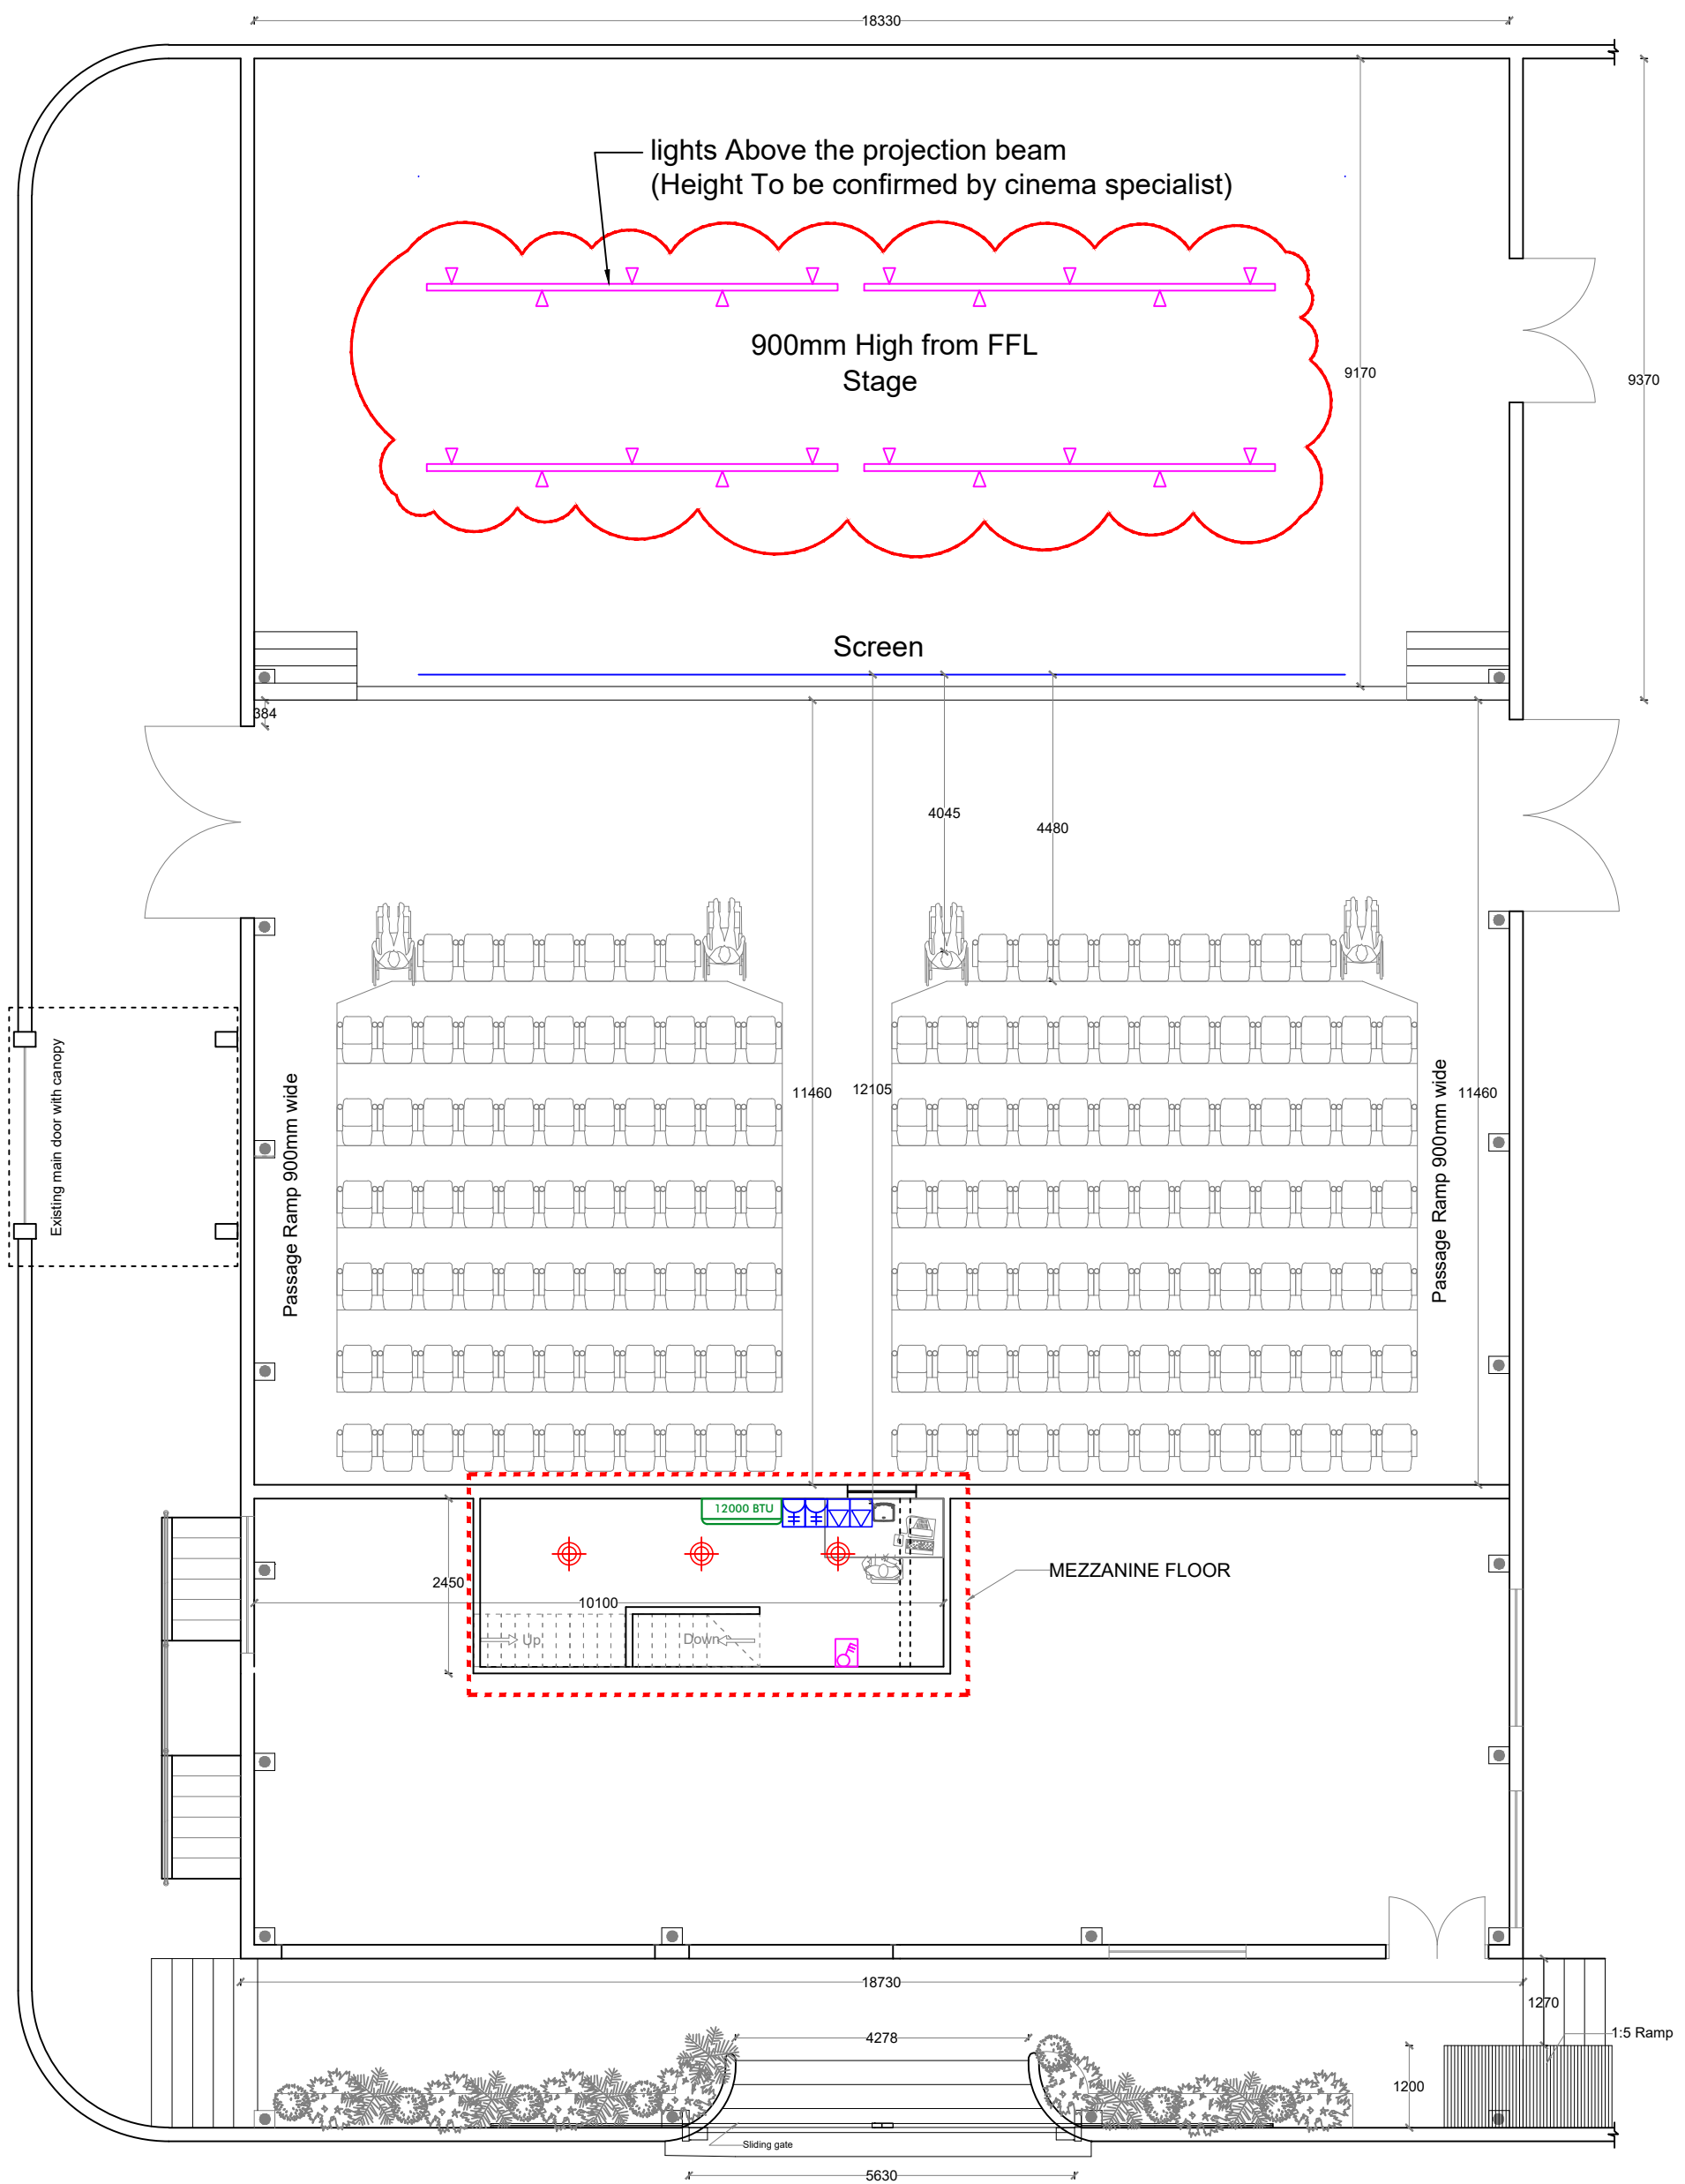

NB : Dimension and details in the drawings are approximate only. Contractor must take site measurements, prepare shop drawings and method statements where needed during construction.

PROPOSED LAYOUT- CINEMA


C-6M	Scale : 1:100
	Drawing: Lighting, Power & Data. SME HUB - Mezzanine Floor HDh. Kulhudhuffushi
	All Dimensions are in mm

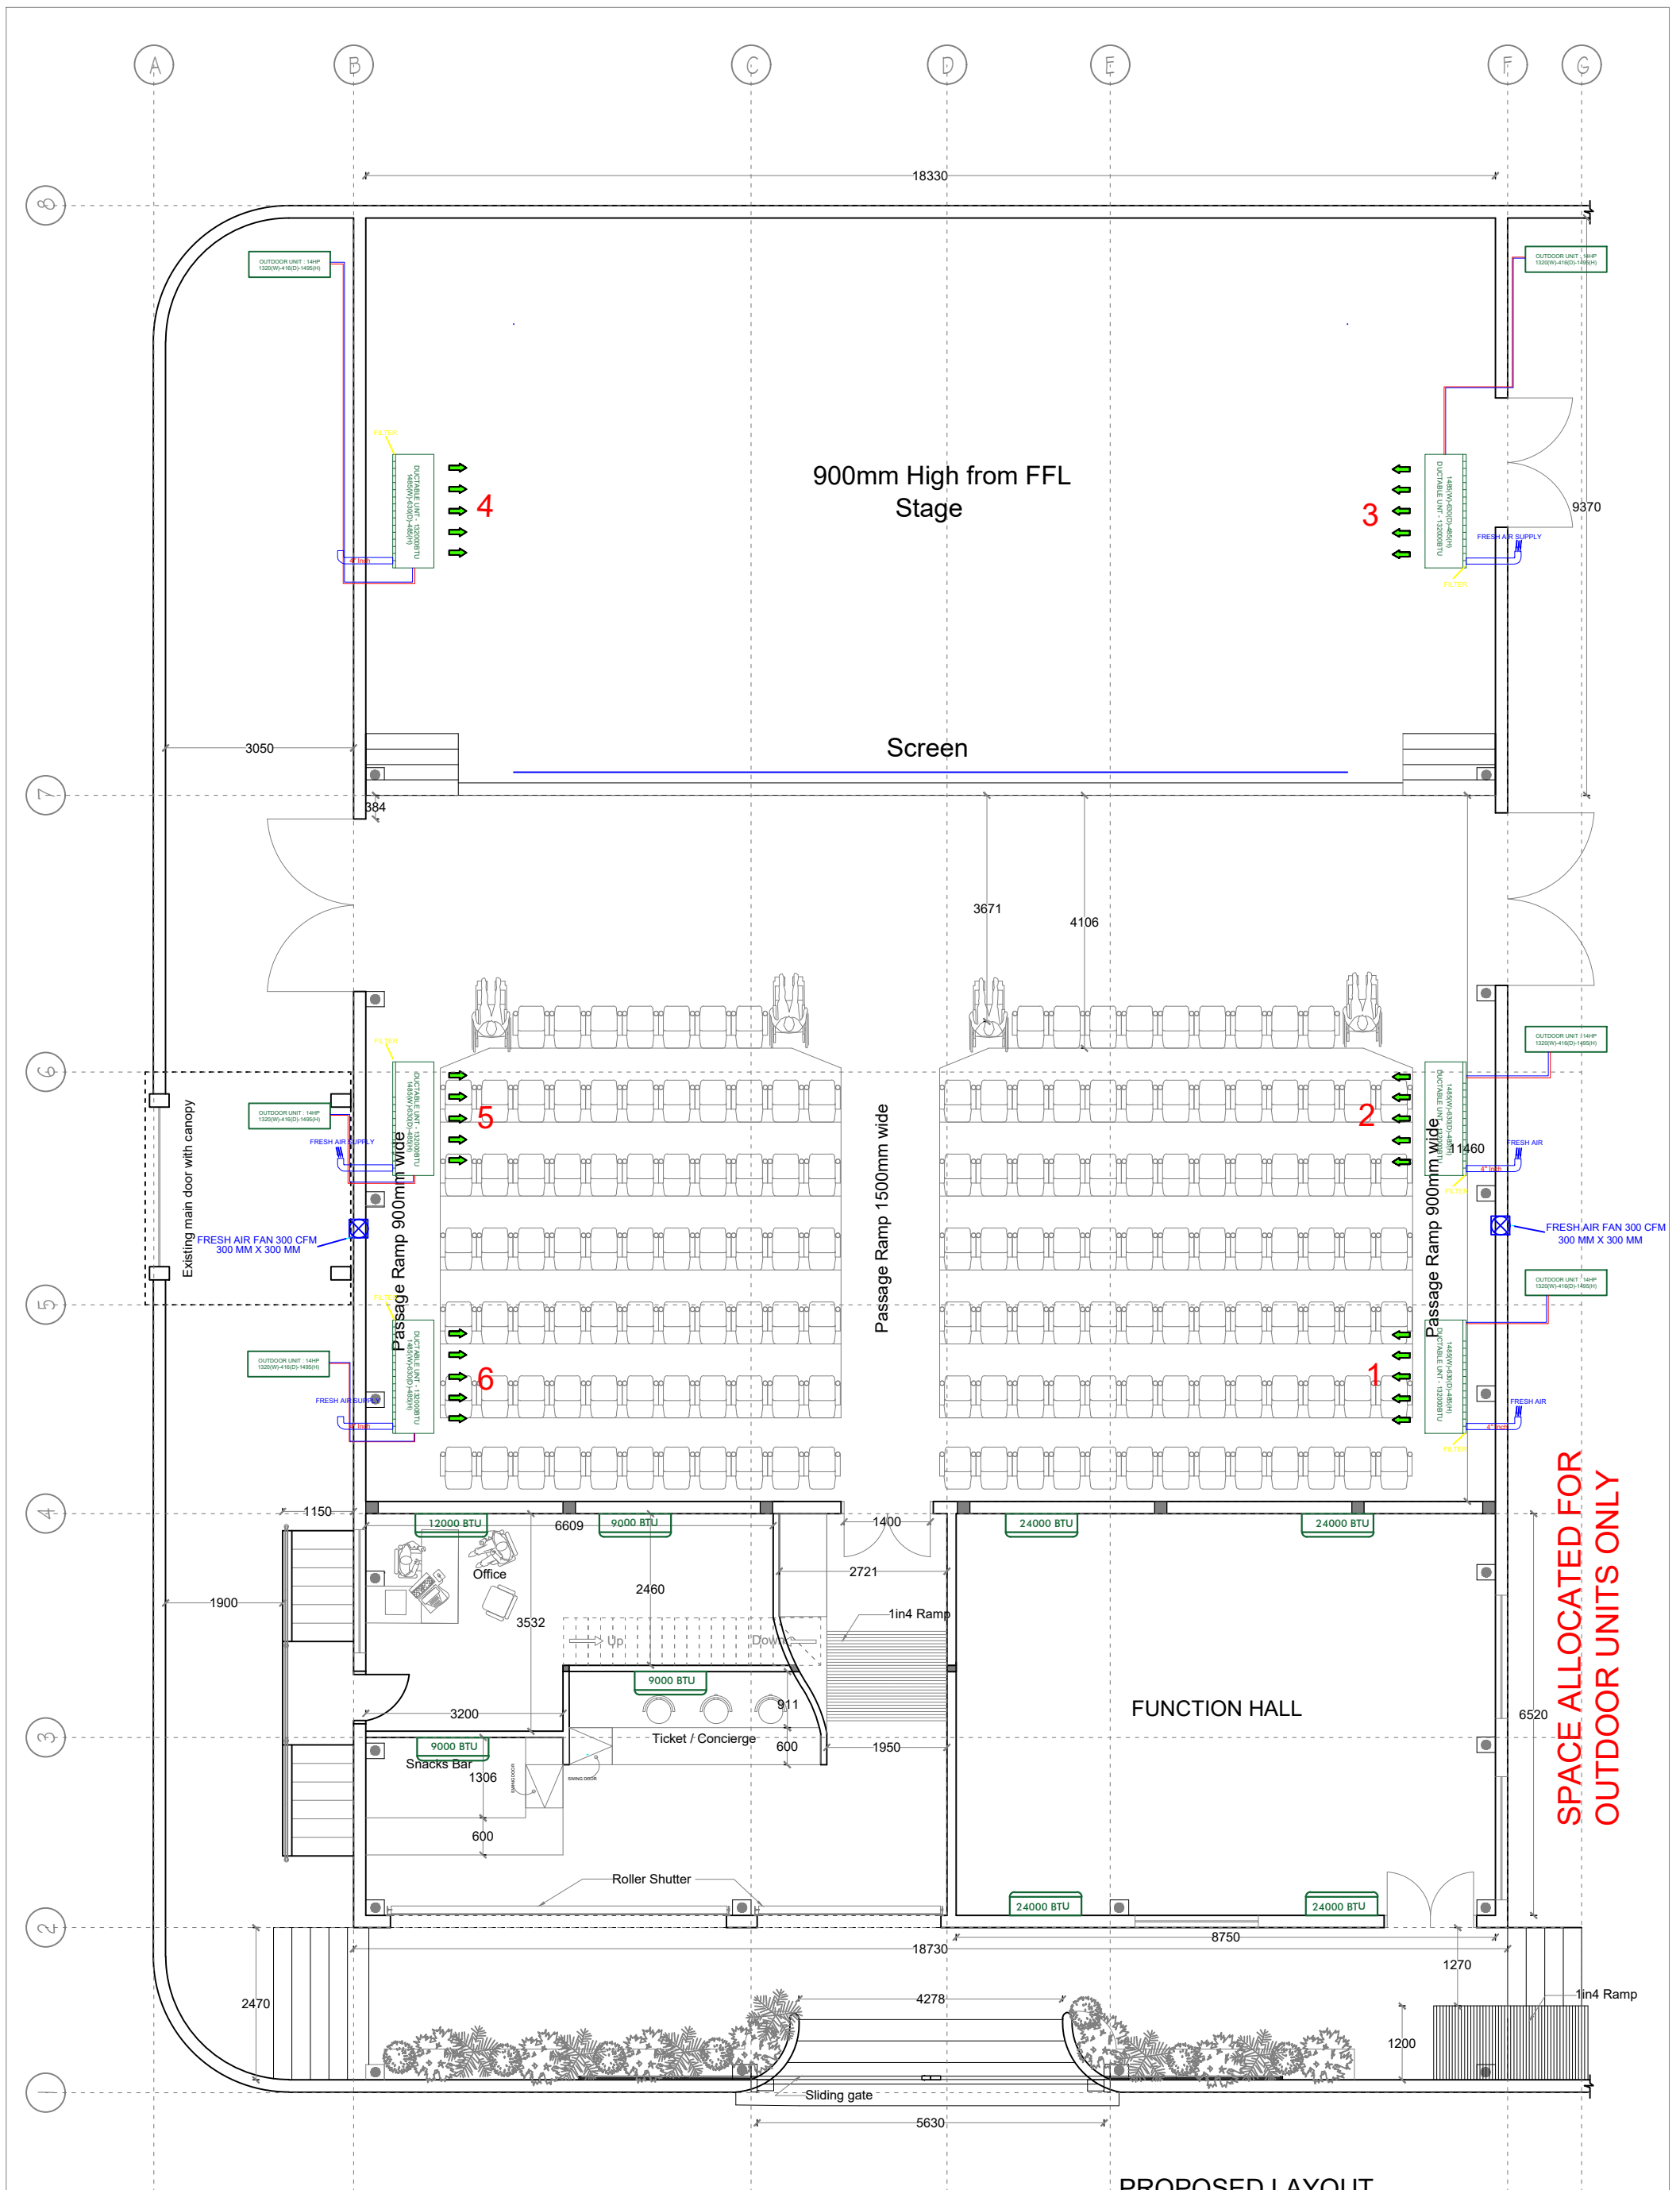

NB : Dimension and details in the drawings are approximate only. Contractor must take site measurements, prepare shop drawings and method statements where needed during construction.

PROPOSED LAYOUT

C-7	Scale : 1:100
	Drawing: AC Layout
	SME HUB HDh. Kulhudhuffushi
	All Dimensions are in mm

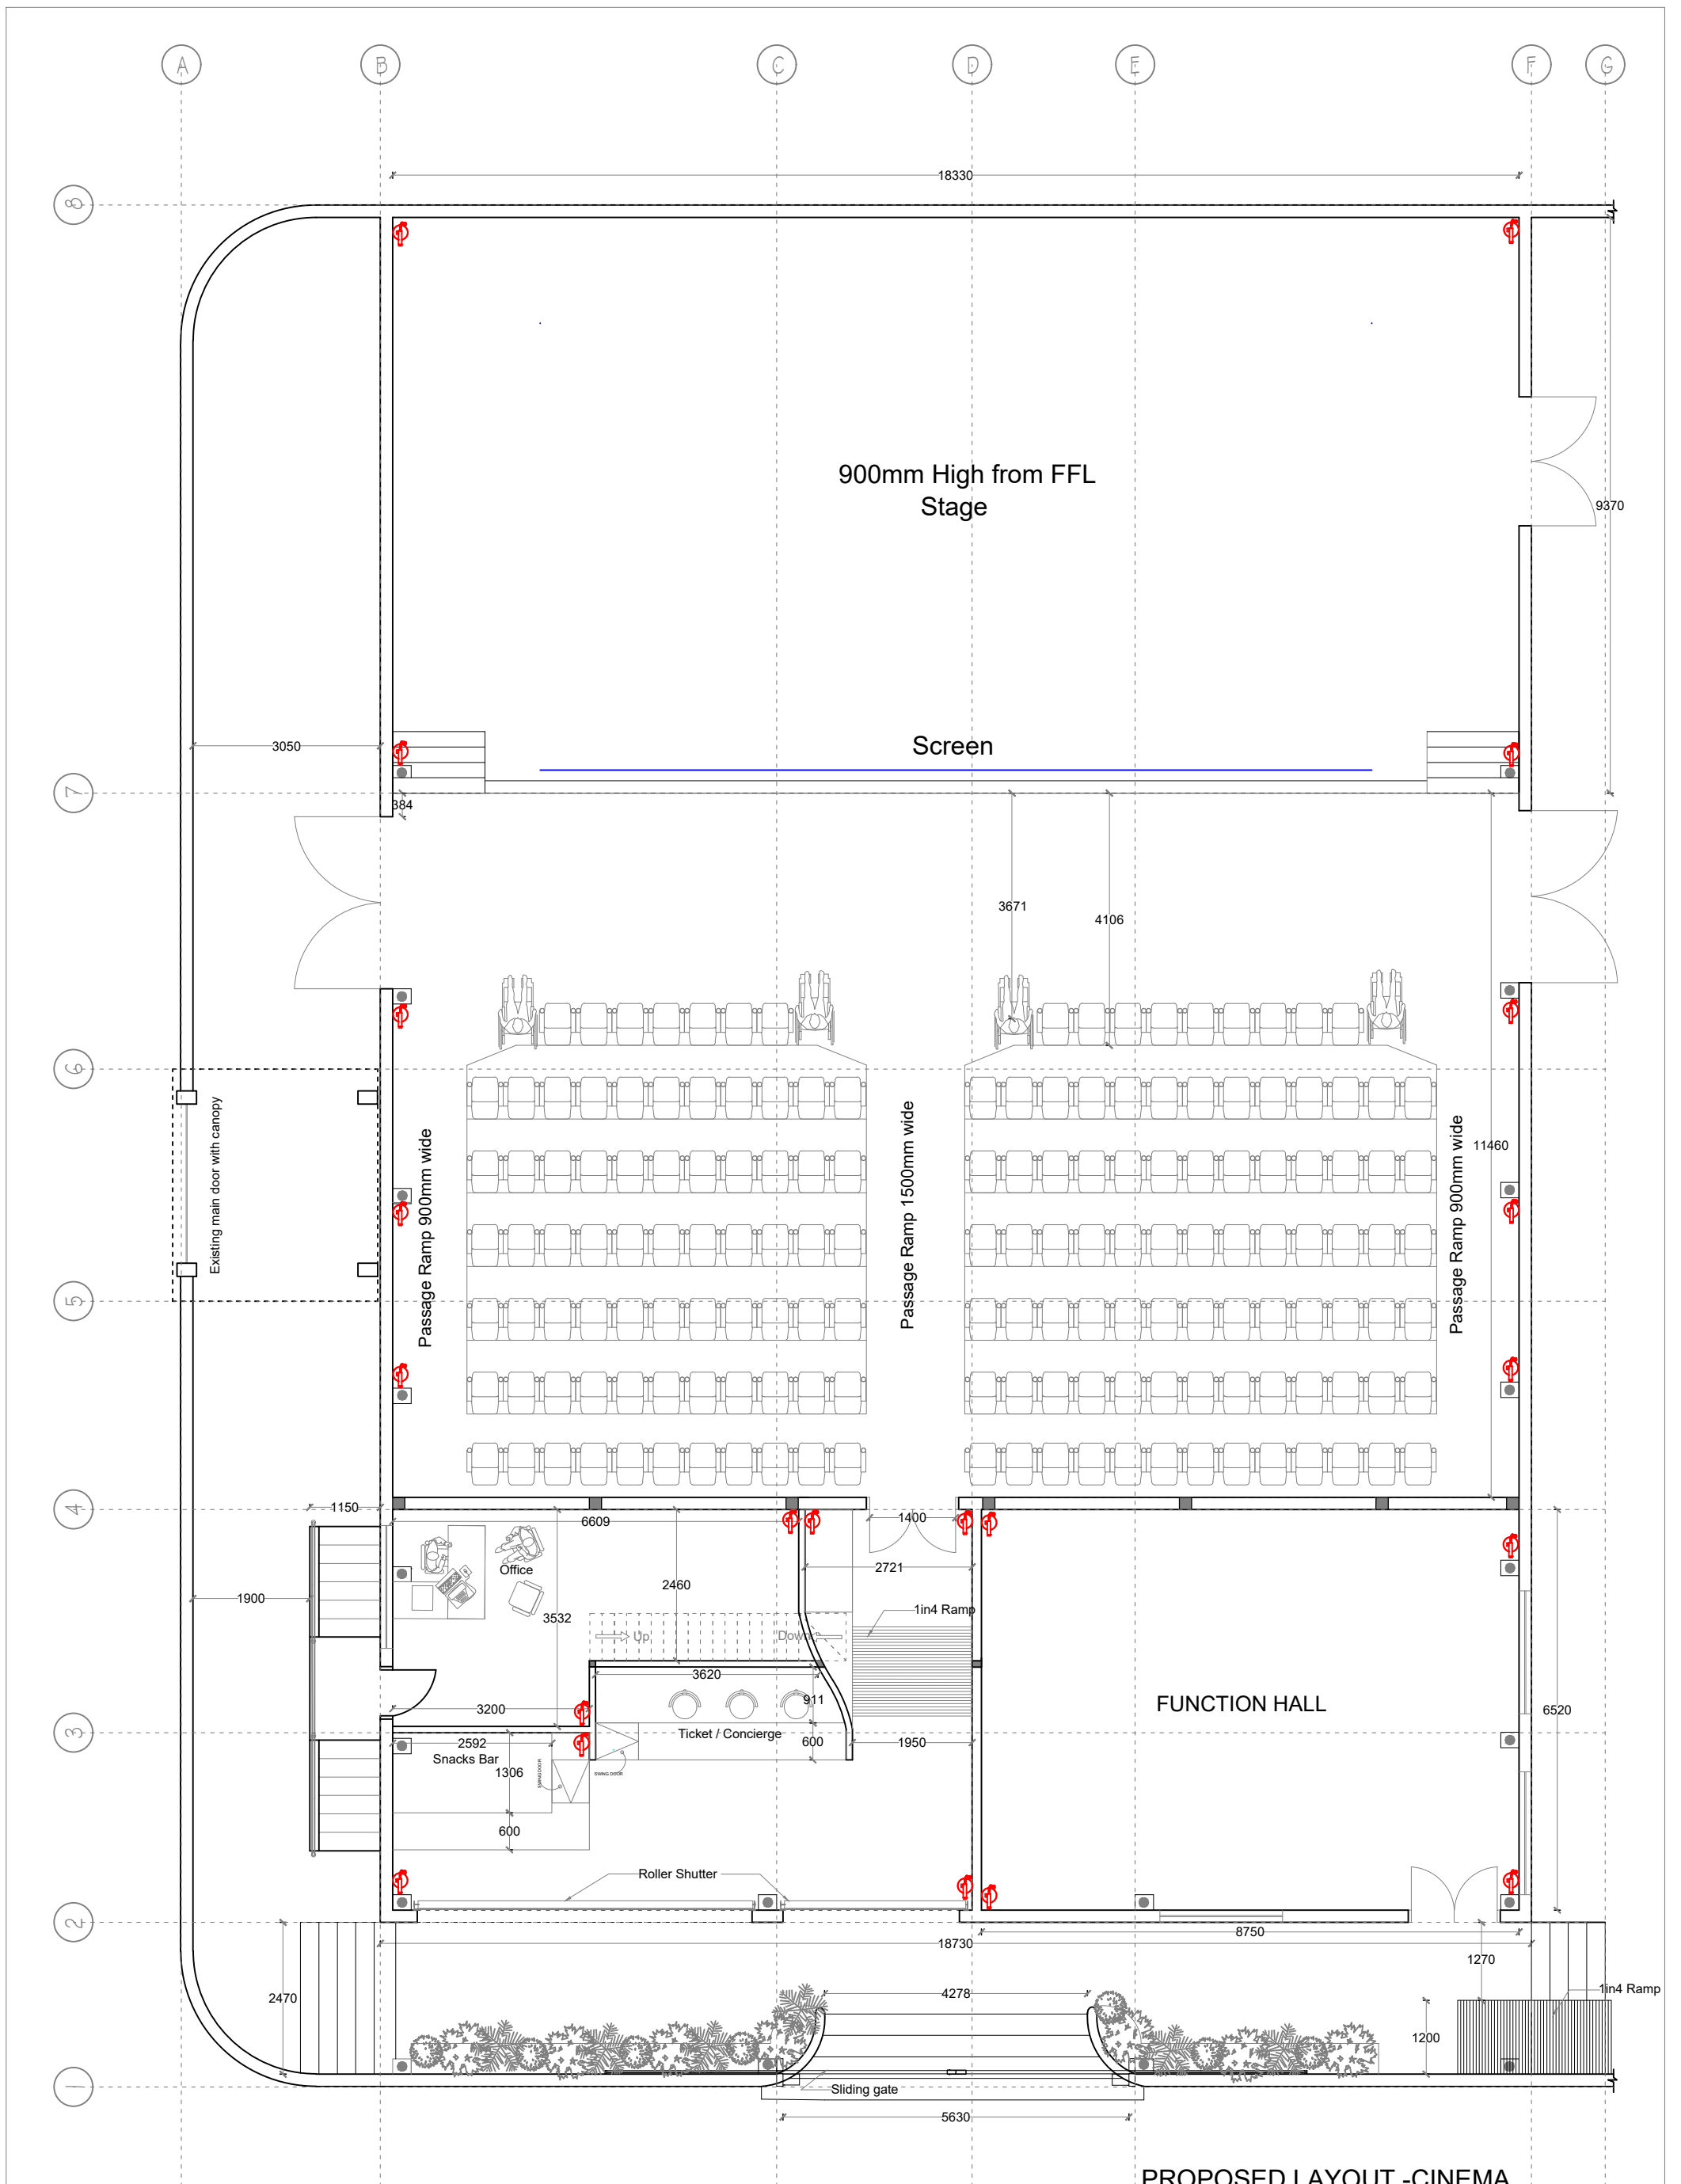


 - Fire Extinguisher

NB : Dimension and details in the drawings are approximate only. Contractor must take site measurements, prepare shop drawings and method statements where needed during construction.

PROPOSED LAYOUT -CINEMA

C-8	Scale : 1:100
	Drawing: Fire indicative SME HUB -Ground floor HDh. Kulhudhuffushi
	All Dimensions are in mm

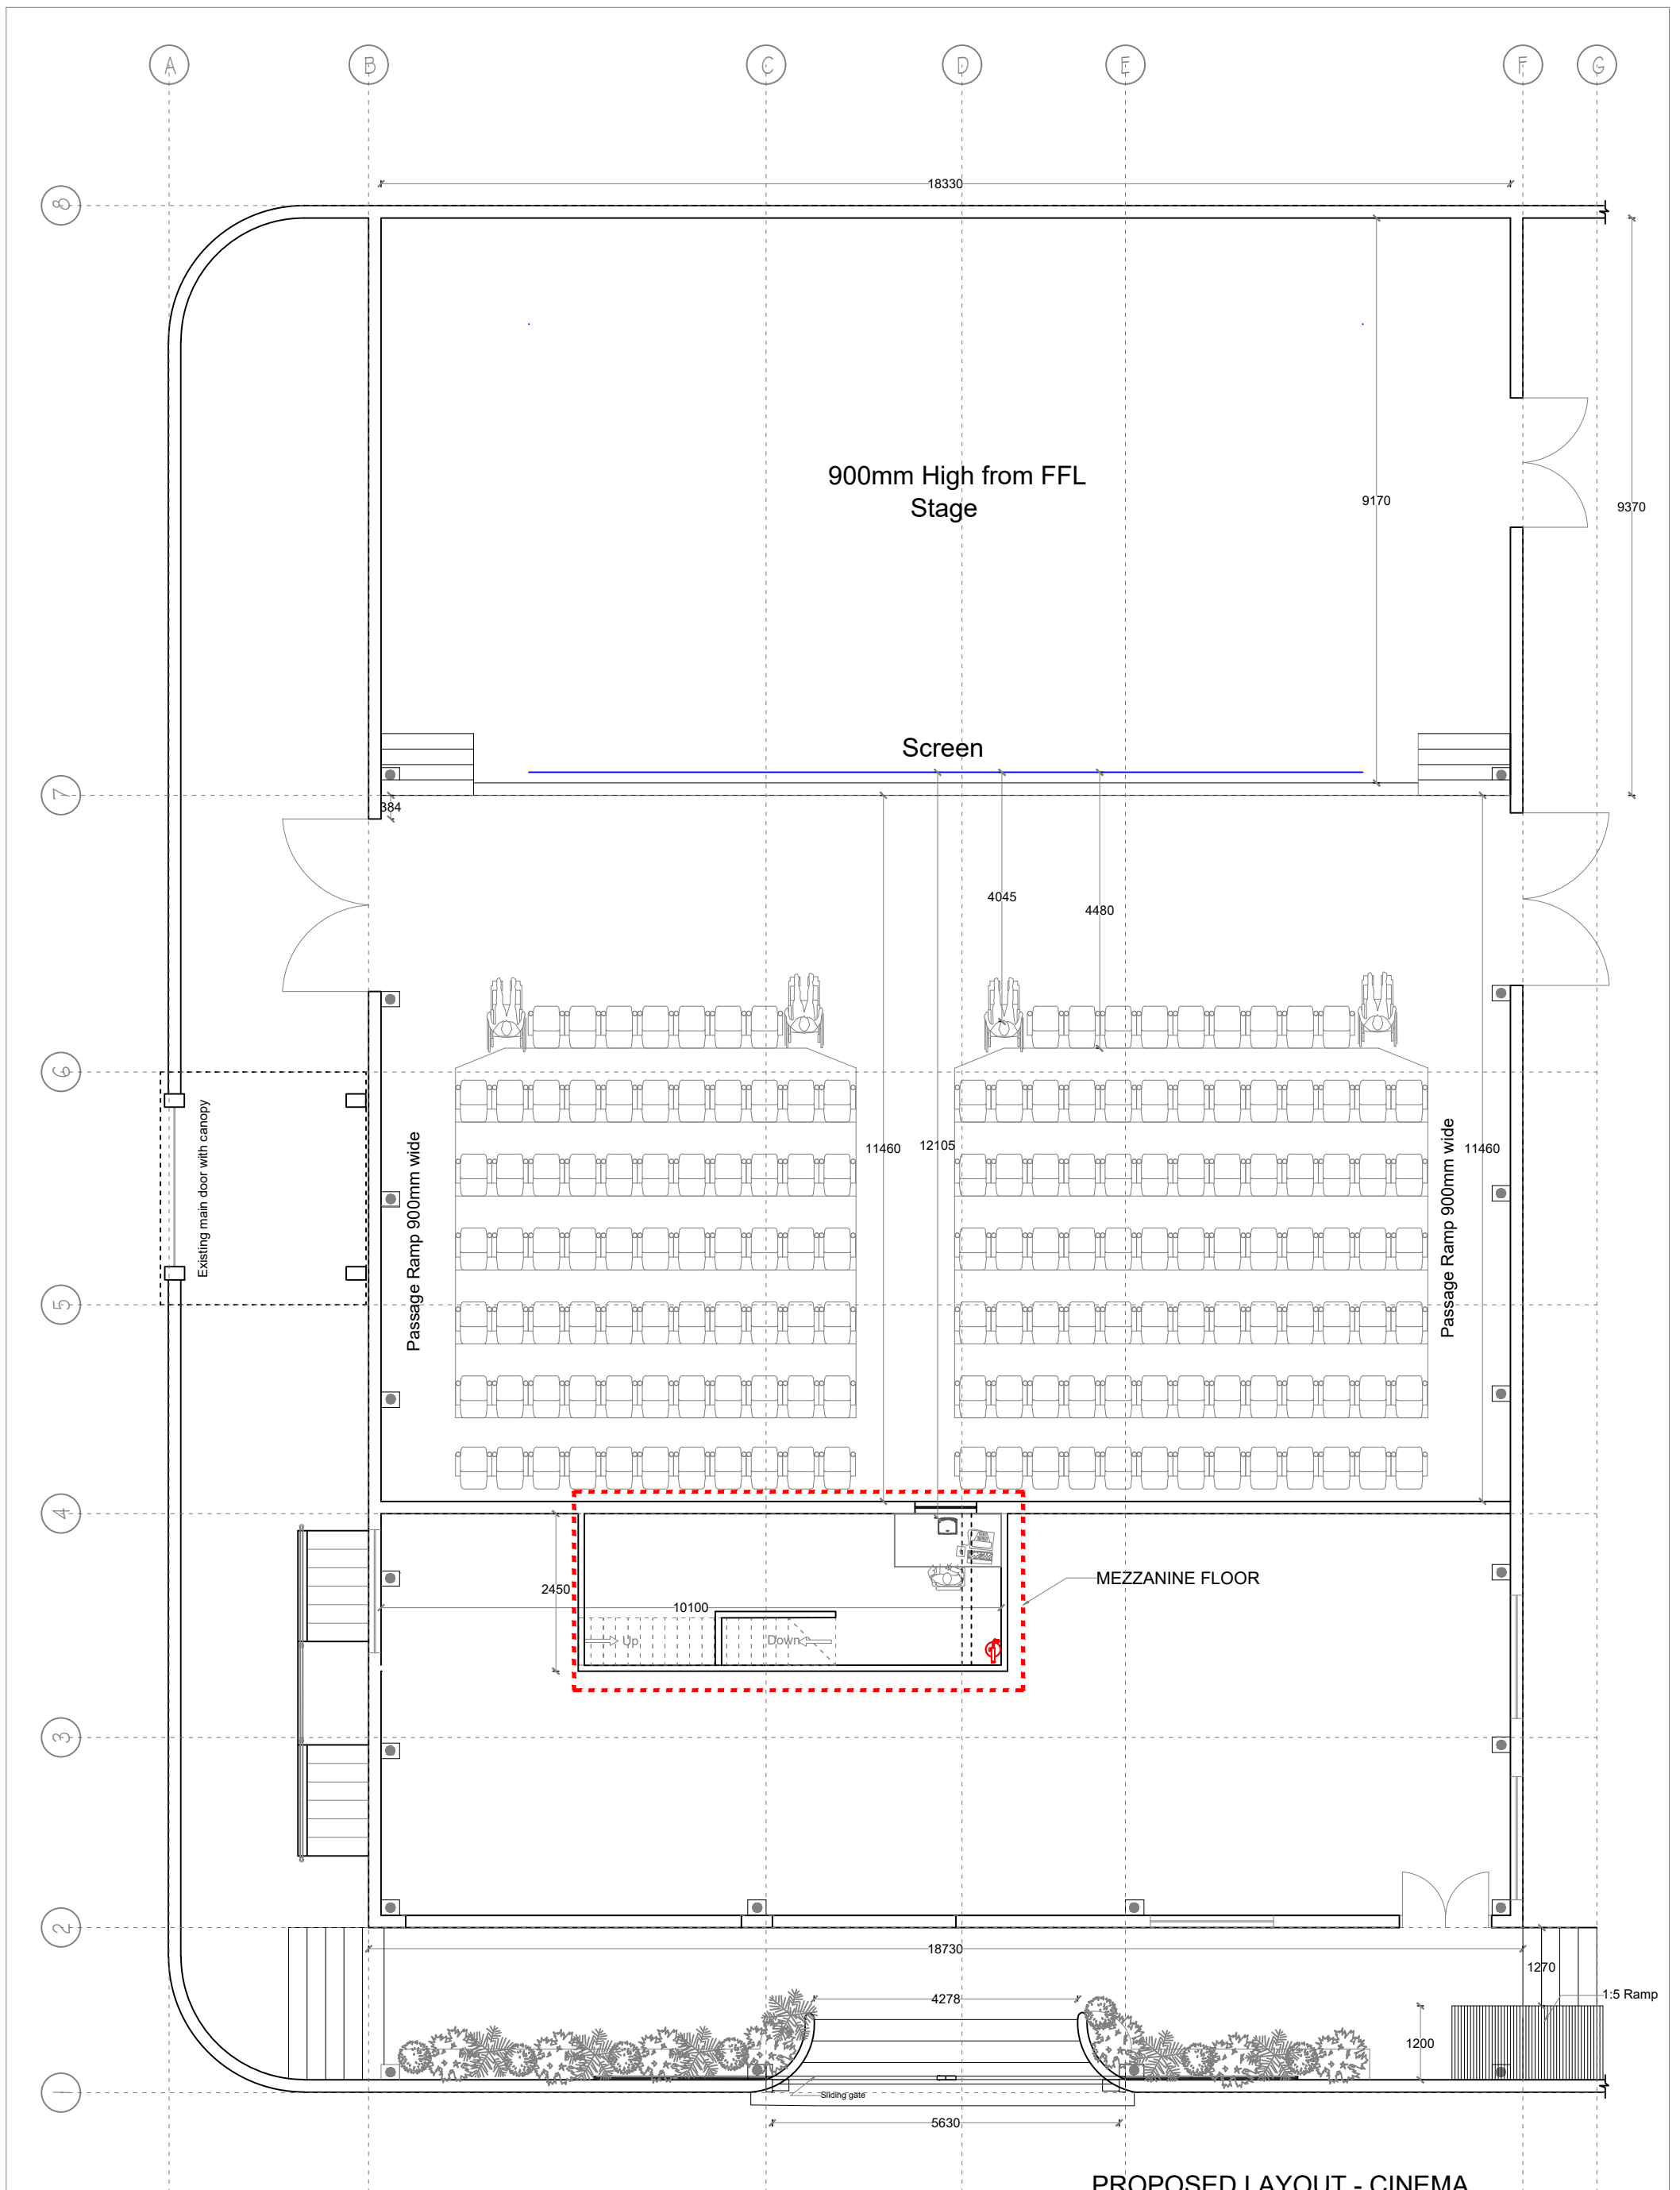

 - Fire Extinguisher

NB : Dimension and details in the drawings are approximate only. Contractor must take site measurements, prepare shop drawings and method statements where needed during construction.

PROPOSED LAYOUT - CINEMA

C-8M	Scale : 1:100
	Drawing: Fire indicative SME HUB- Mezzanine Floor HDh. Kulhudhuffushi
	All Dimensions are in mm