



PROFINISHES

PROJECT:

MALDIVES HAJJ CORPORATION LIMITED



مؤسسة الحج الملهية المحدودة
MALDIVES HAJJ CORPORATION LIMITED
مؤسسة الحج الملهية المحدودة





މާލިދީބު ހާލް ކޯޕަރޭޝަން ލިމިޓެޑް
MALDIVES HALL CORPORATION LIMITED










FLOOR PLAN
SCALE 1:50



LEGEND

CODE	DESCRIPTION	QTY
FD-01	LOUNGE CHAIRS	12
FD-02	LOUNGE TABLES	06
FD-03	OFFICE CHAIR	14
FD-04	RECEPTION COUNTER	01
FD-05	MEETING ROOM TABLE	01
FD-06	MEETING ROOM CABINET	01
FD-07	DISPLAY CABINET	02
FD-08	DISPLAY CABINET	01
FD-09	OPEN DISPLAY SHELVES	01
FD-10	FREE STANDING LOW DISPLAY	02


FURNITURE LAYOUT
SCALE 1:50

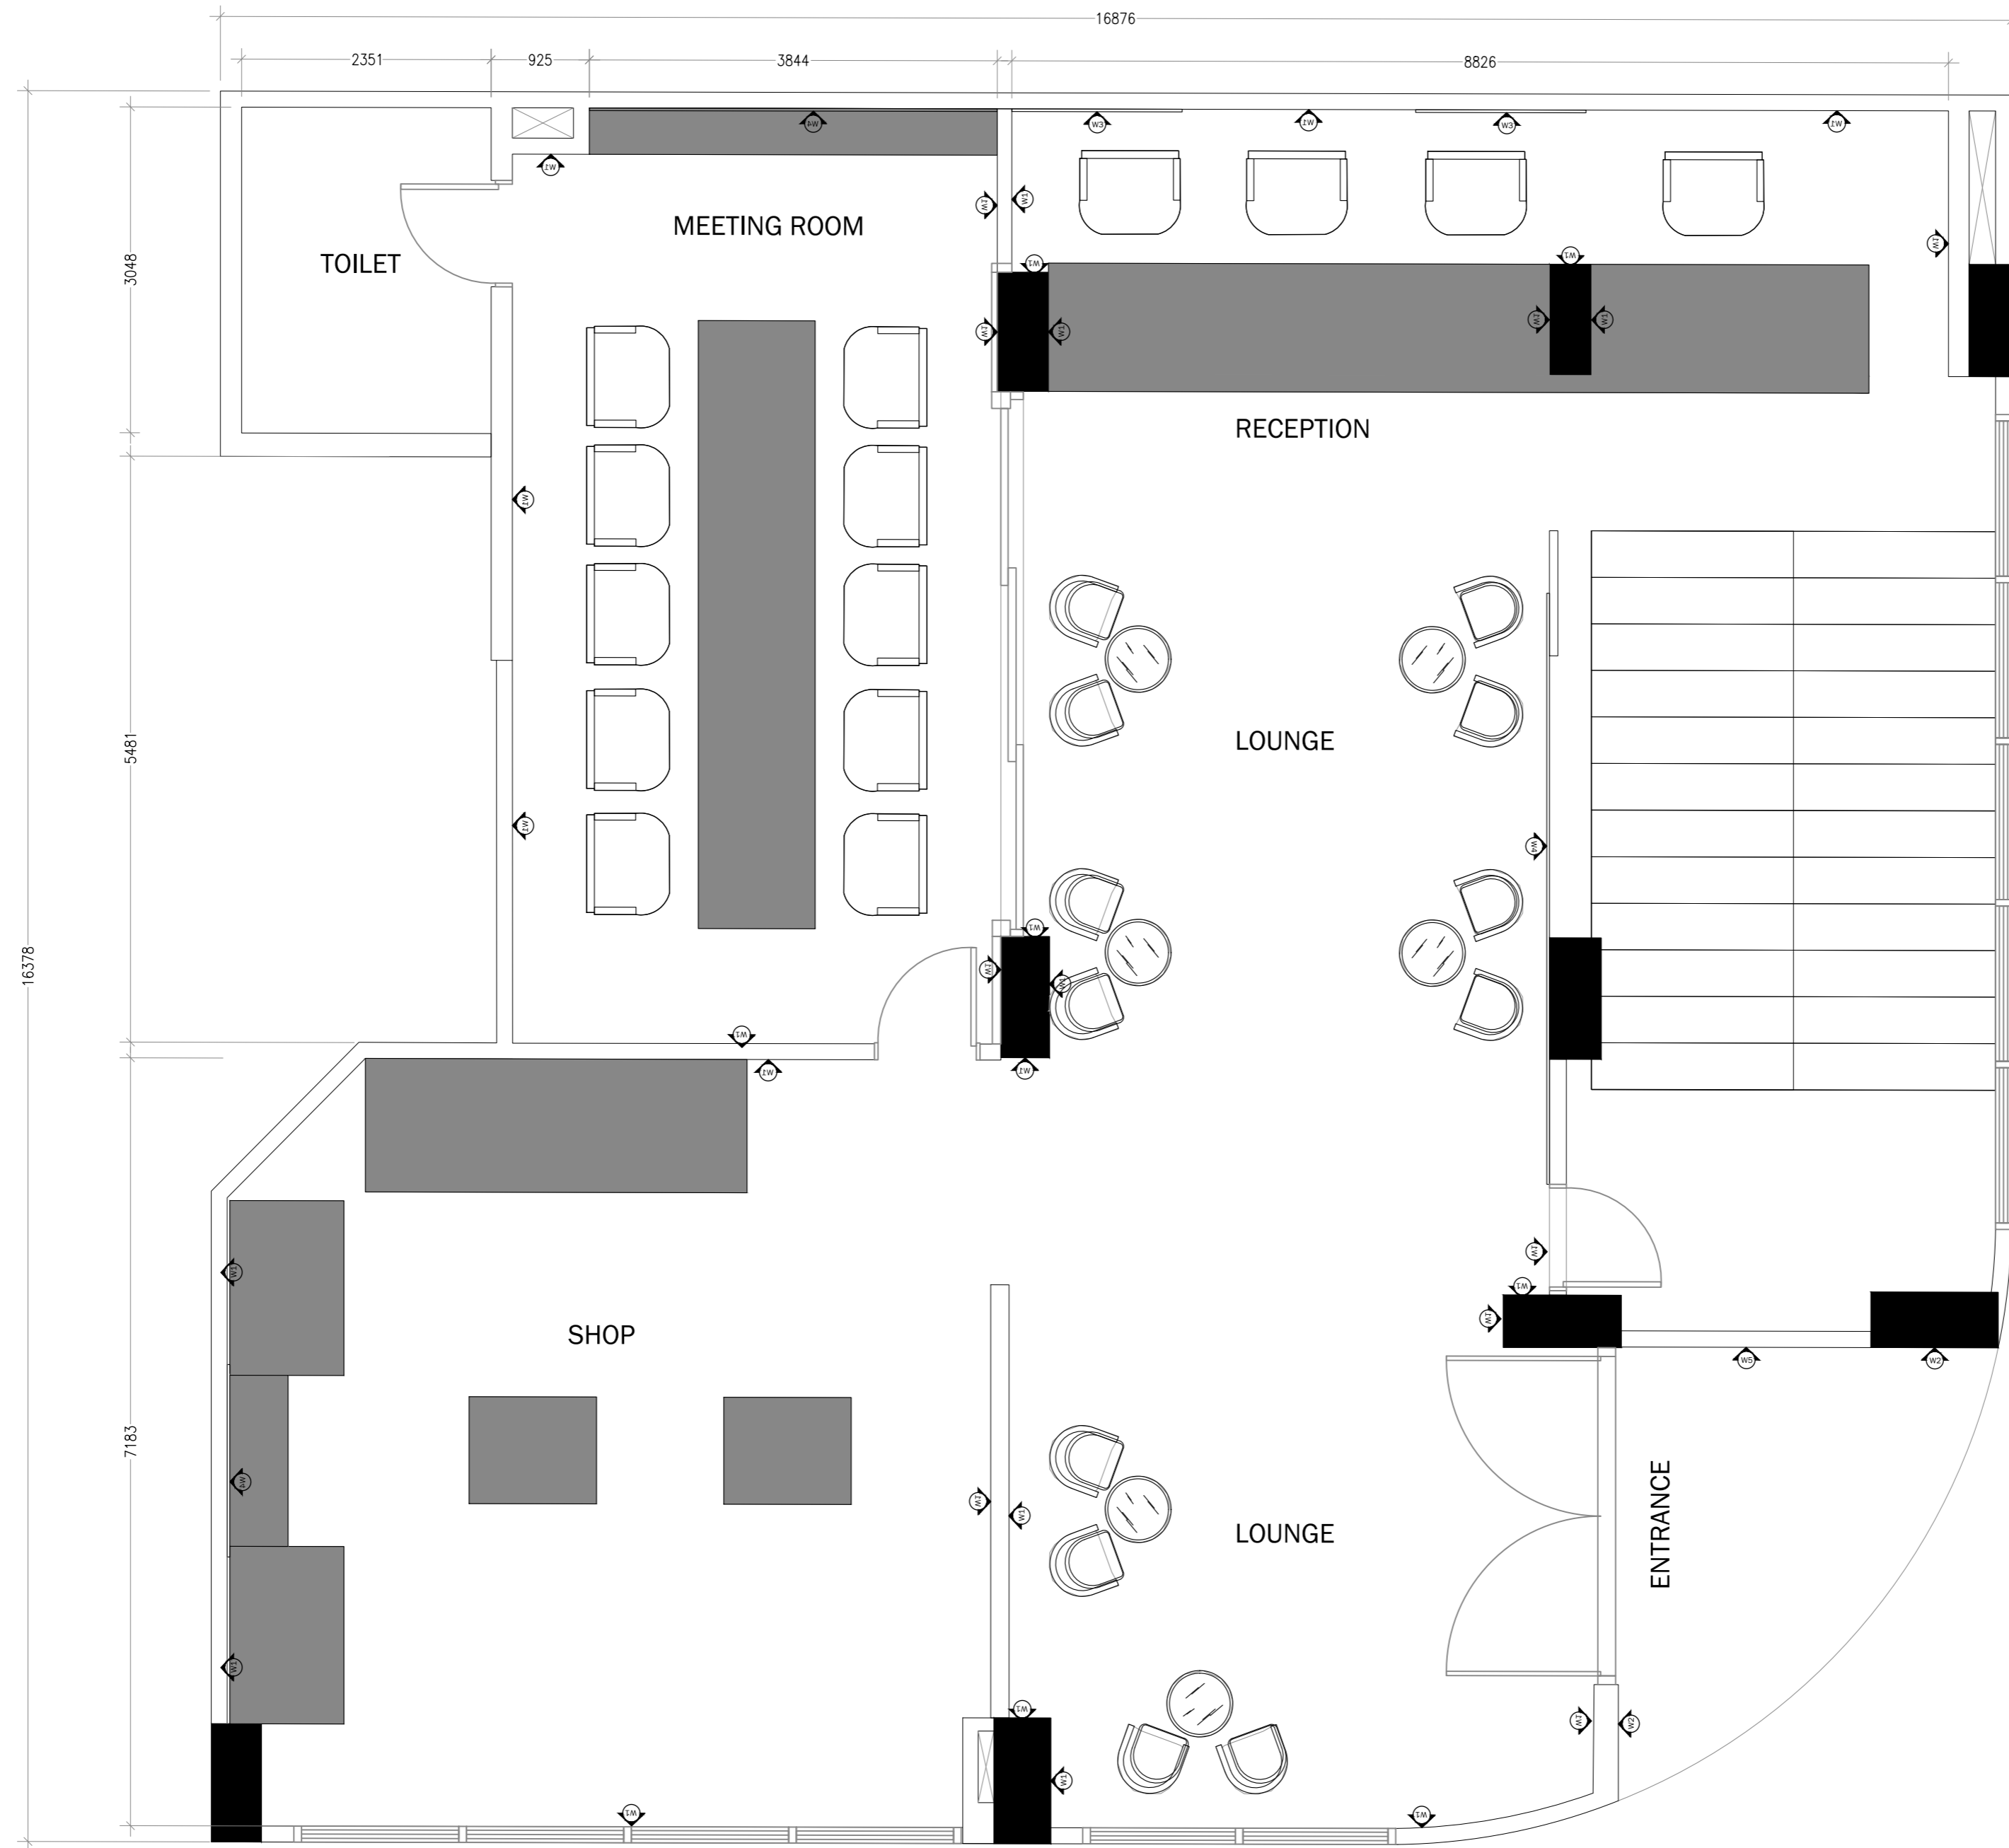

LEGEND

SYMBOL	IMAGE	DESCRIPTION
W1		WALL PAINT- COLOR SAGE CODE- 0004C SH S 2010-G20Y SOURCE- SAMHWA
W2		WALL PAINT CODE- 0001A SH S 0300-N SOURCE- SAMHWA
W3		FLUTED PANEL- WOOD FINISH SOURCE- DREAMTERIORS
W4		JAALI PATTERN GRILL GOLD COLOR PAINT FINISH
W5		JAALI PATTERN GRILL WHITE COLOR PAINT FINISH


WALL FINISH
SCALE 1:50

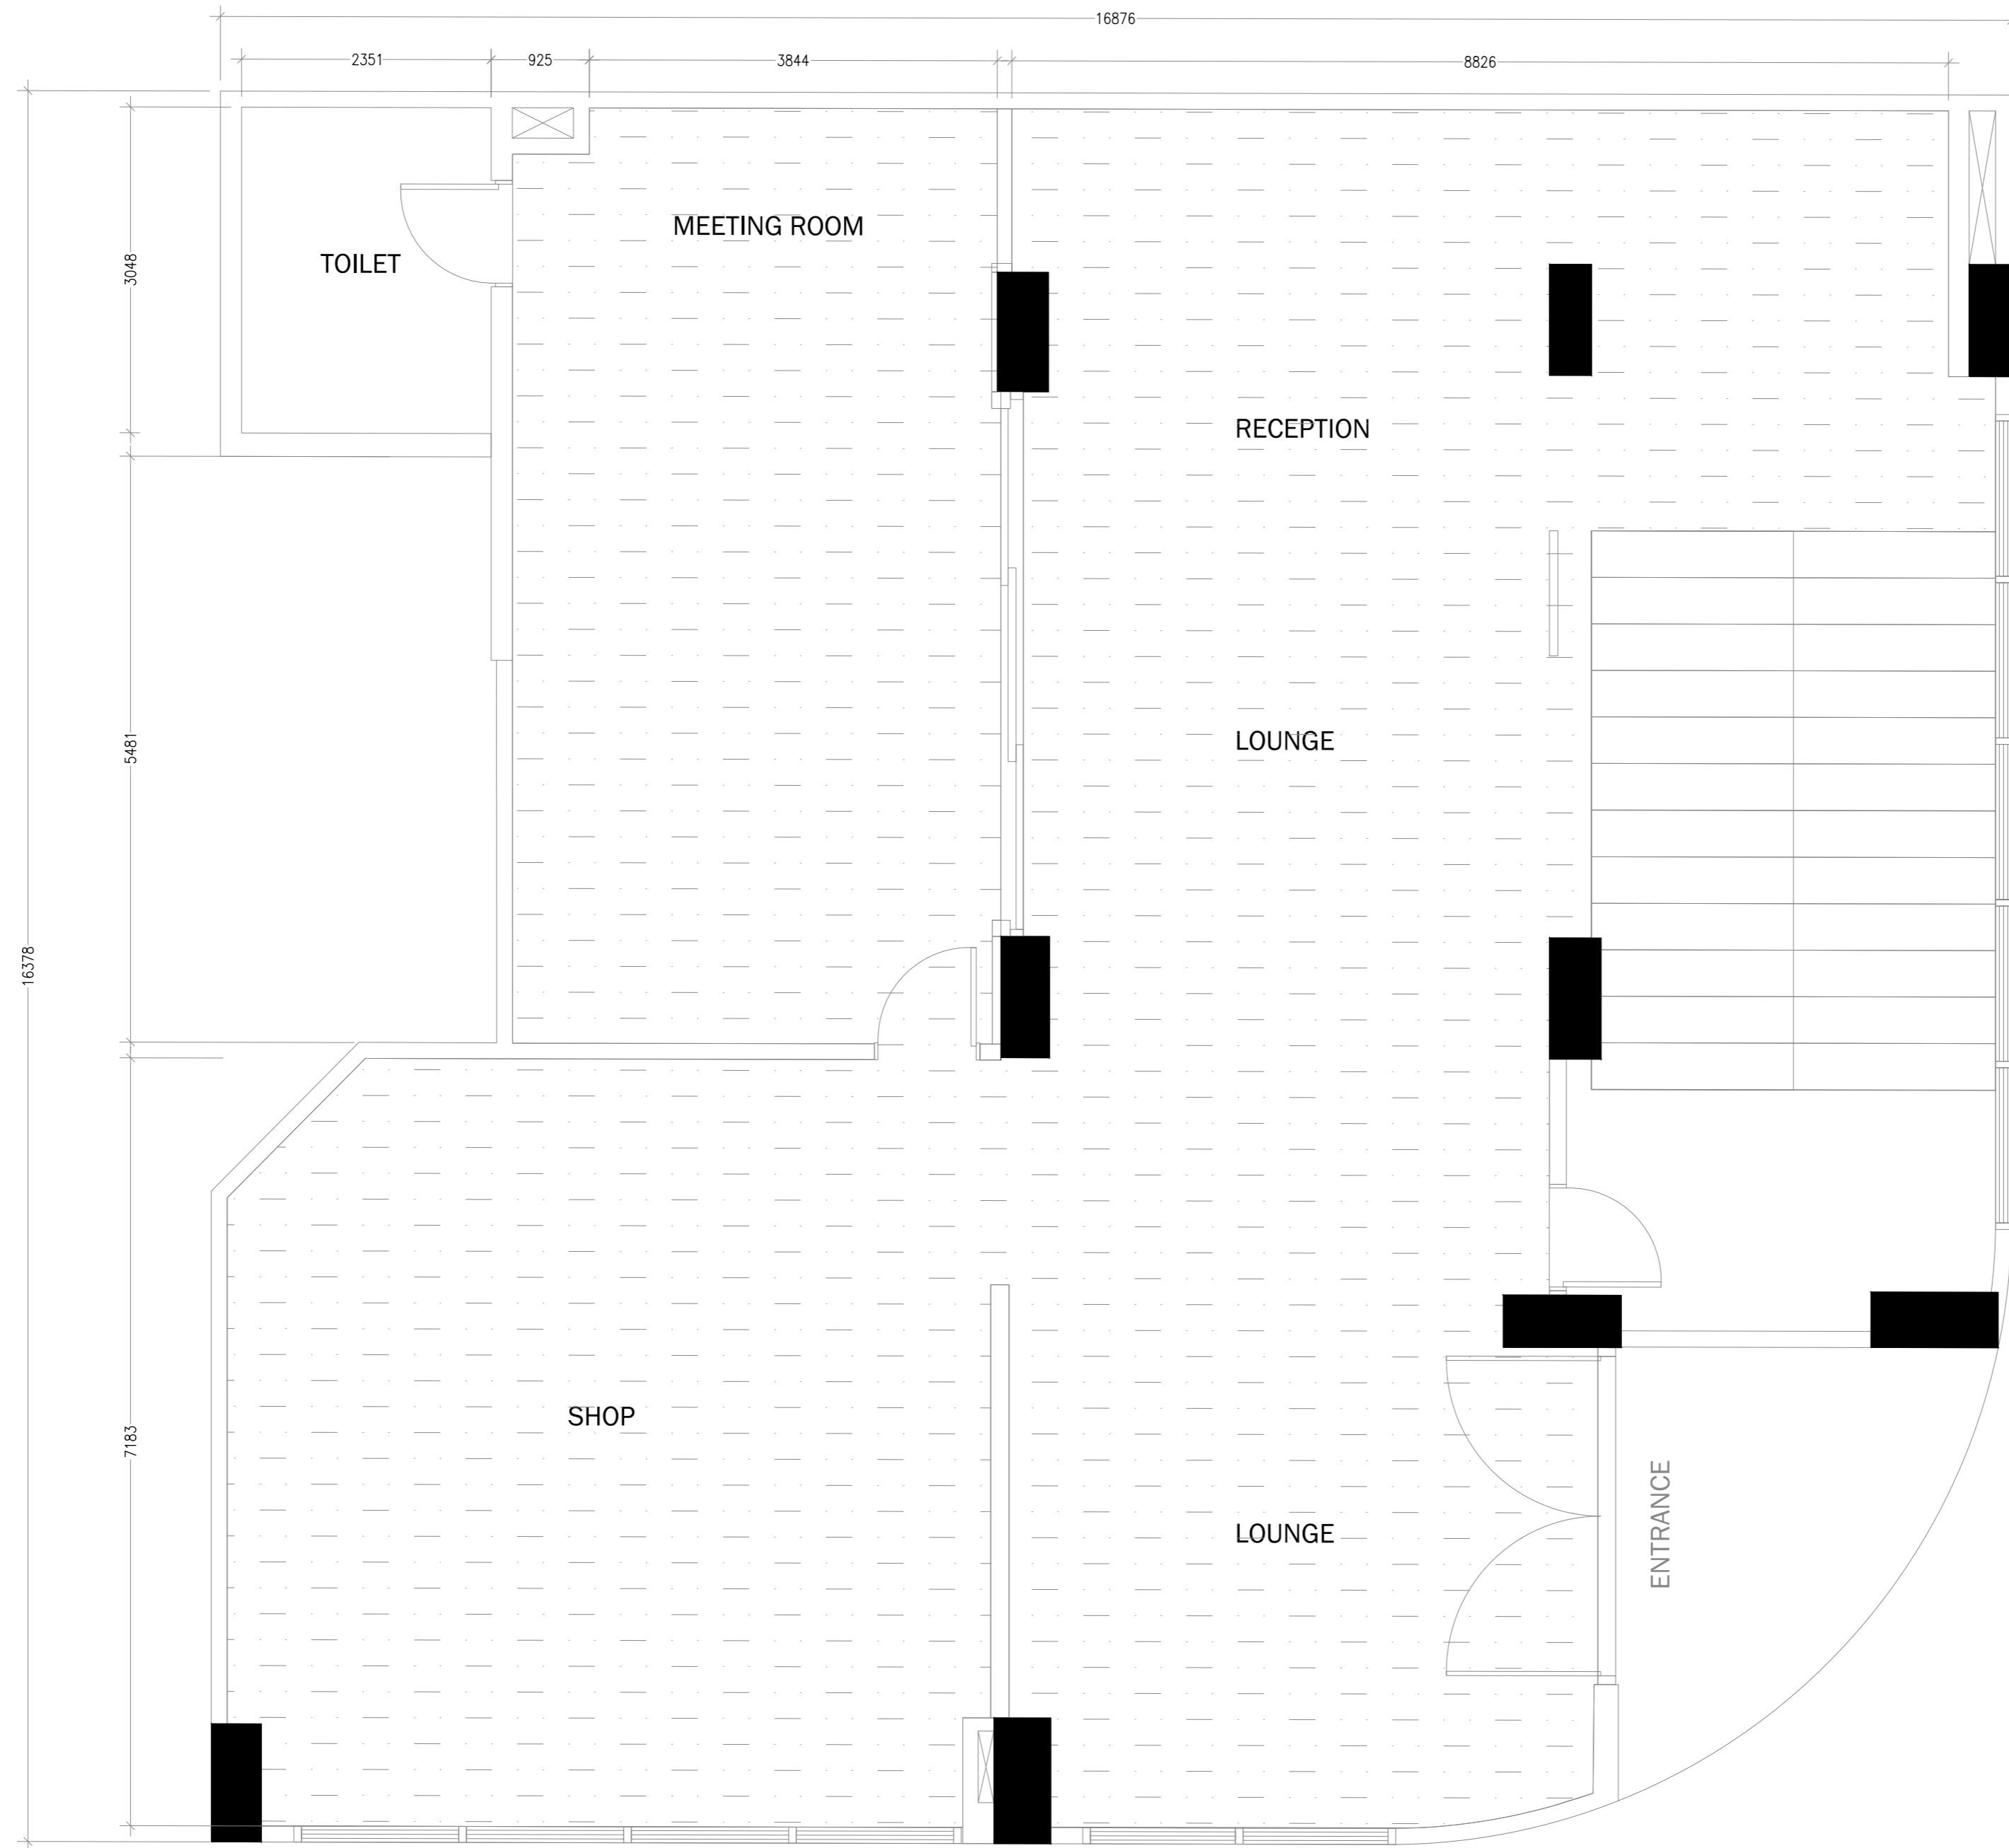

LEGEND

HATCH	IMAGE	DESCRIPTION
		CARPET FLOORING EXPANSION POINT 911 SOURCE- ESSENTIA

FLOOR FINISH
SCALE 1:50

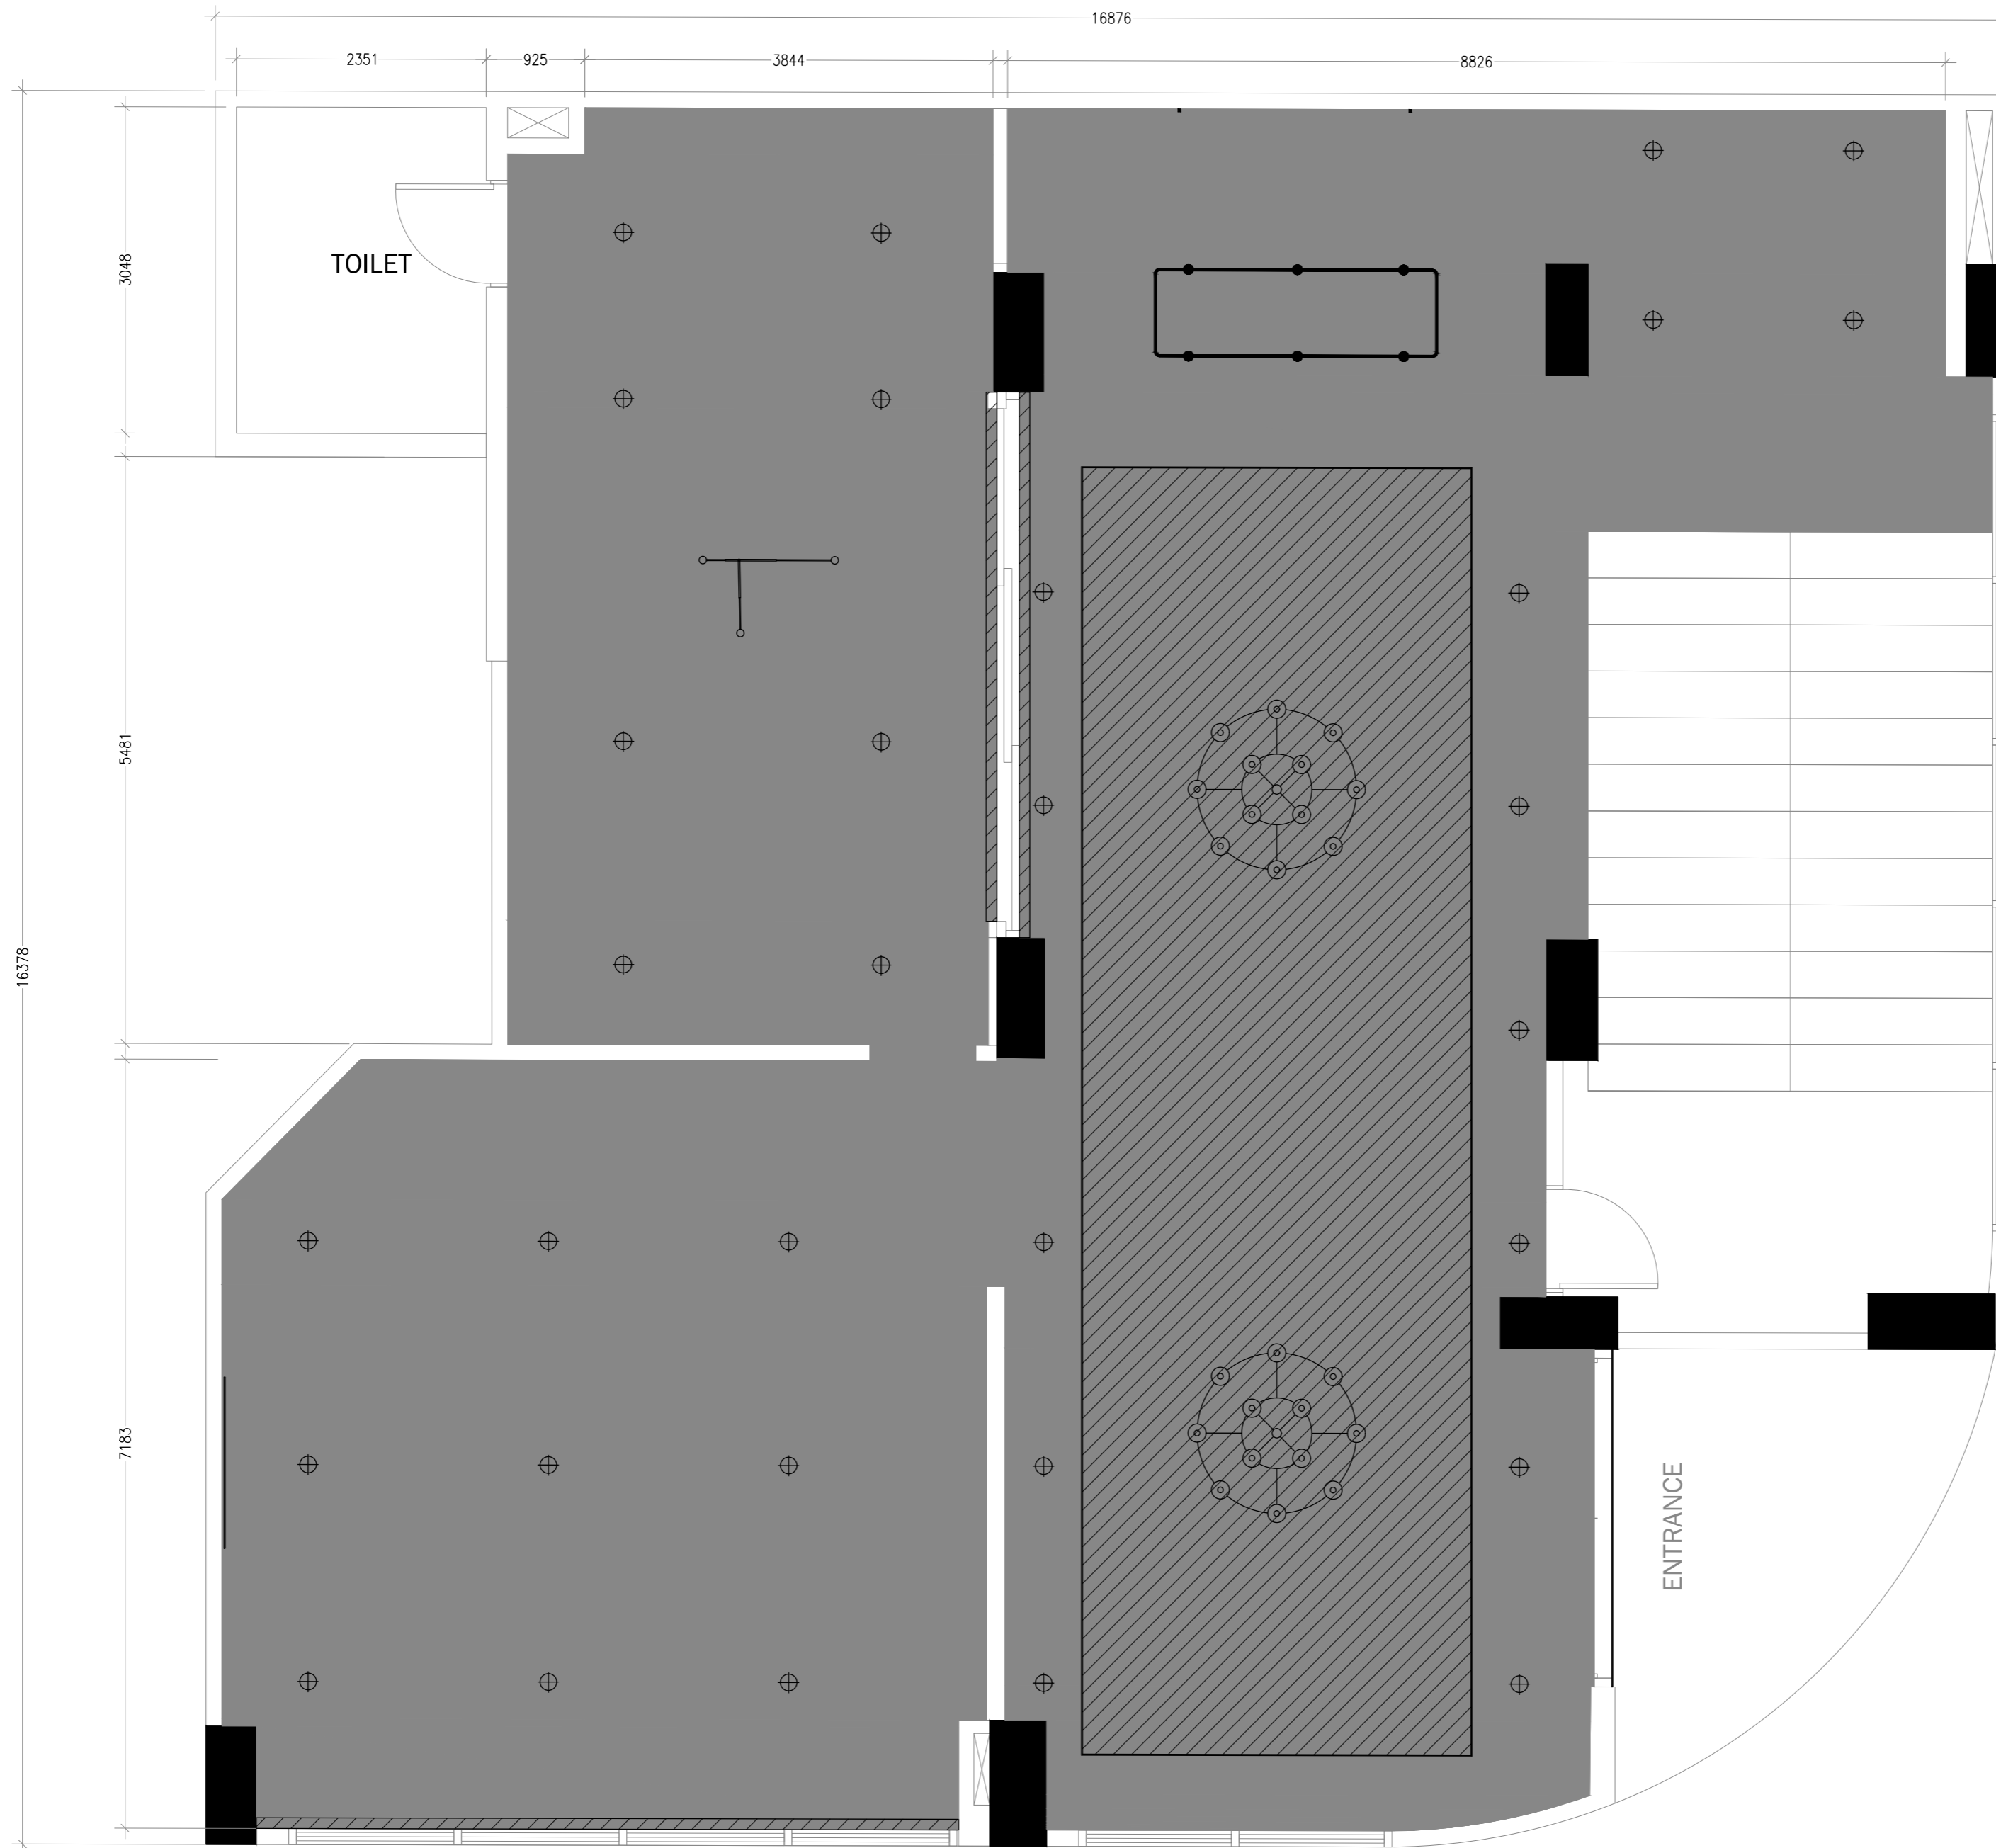


LIGHT LEGEND

SYMBOL	IMAGE	DESCRIPTION
		CHANDHELIER
		RECESSED CEILING LIGHT
		LINEAR PENDANT
		LOOP LINEAR PENDANT LIGHT

CEILING LEGEND

HATCH	DESCRIPTION	COLOR
	DROP CEILING @2848 MM	
	DROP CEILING @2948 MM WITH CORNICE	WALL PAINT CODE- 0001C SH S 1000-N SOURCE- SAMHWA


REFLECTED CEILING PLAN
SCALE 1:50

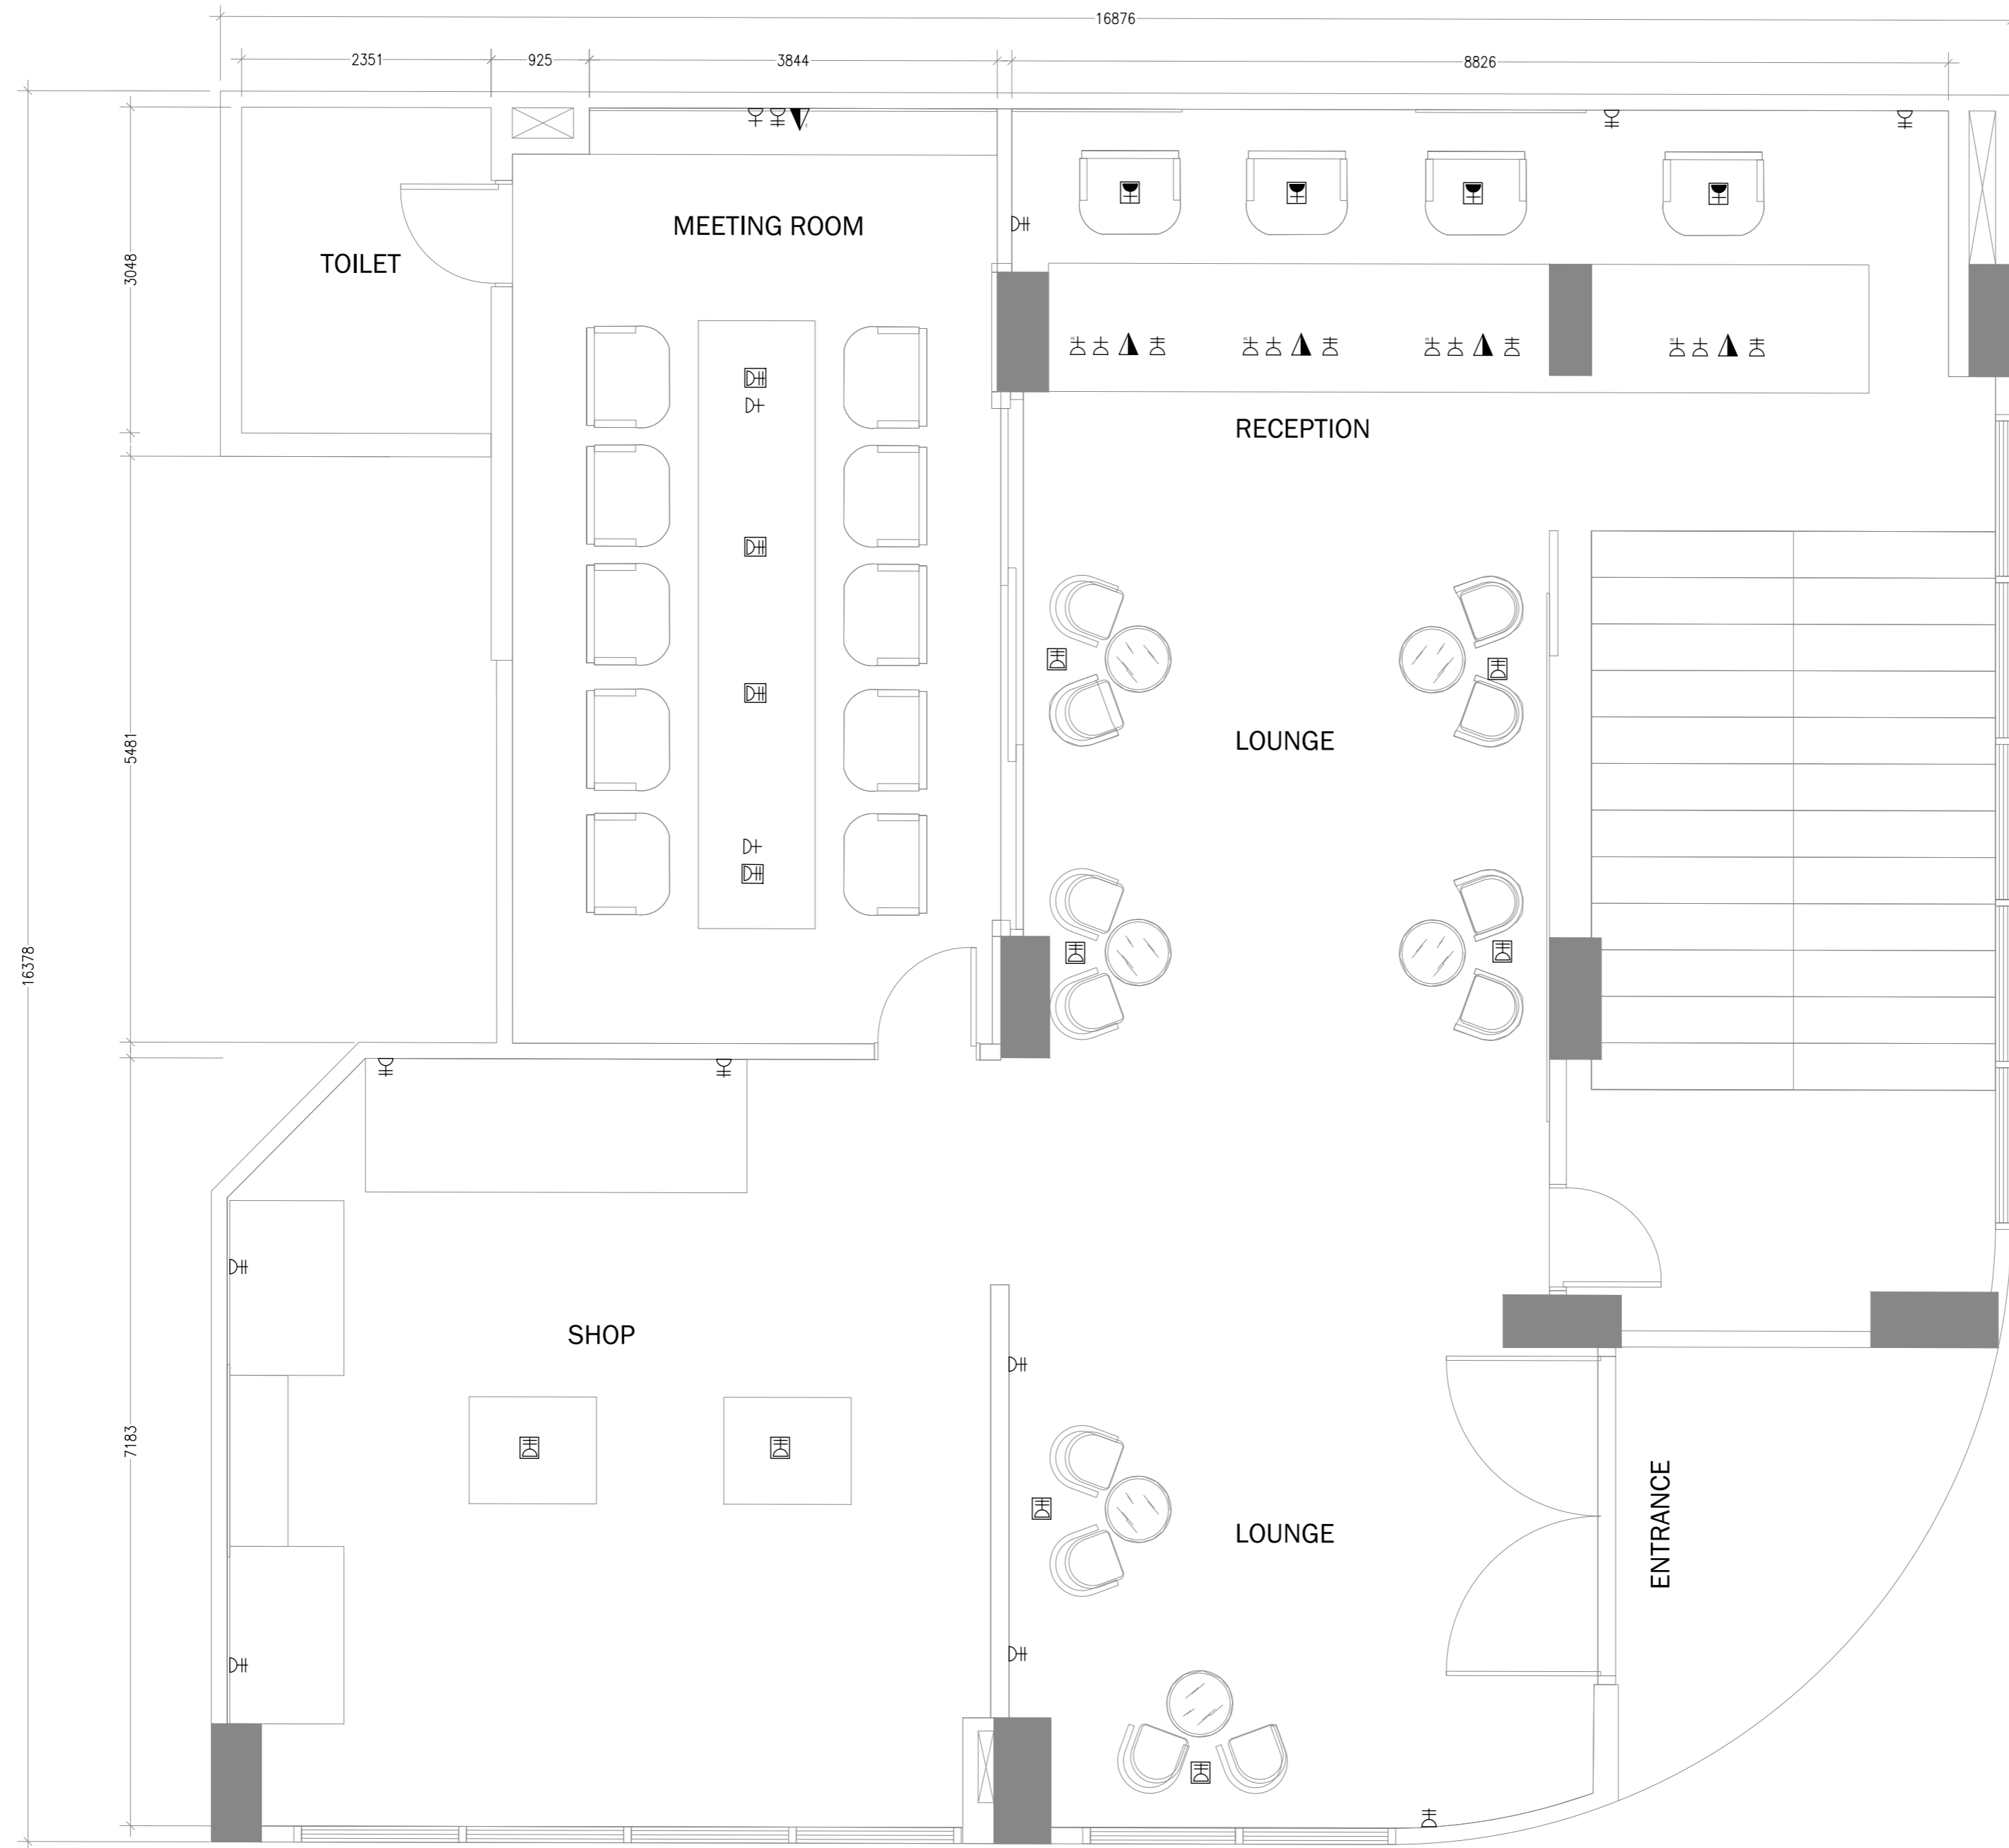


ELECTRICAL LEGEND

SYMBOL	NAME
⌋	13A POWER SOCKET
⌋	13A POWER SOCKET (FIRE EXIT BOARD)
⌋	15A SWITCH SOCKET @ H.L
⌋	13A TWIN SOCKET
⌋	13A TWIN SOCKET FLOOR MOUNT
▲	COMPUTER NETWORK OUTLET
▲	COMPUTER NETWORK OUTLET (2 GANG)


ELECTRICAL PLAN
SCALE 1:50

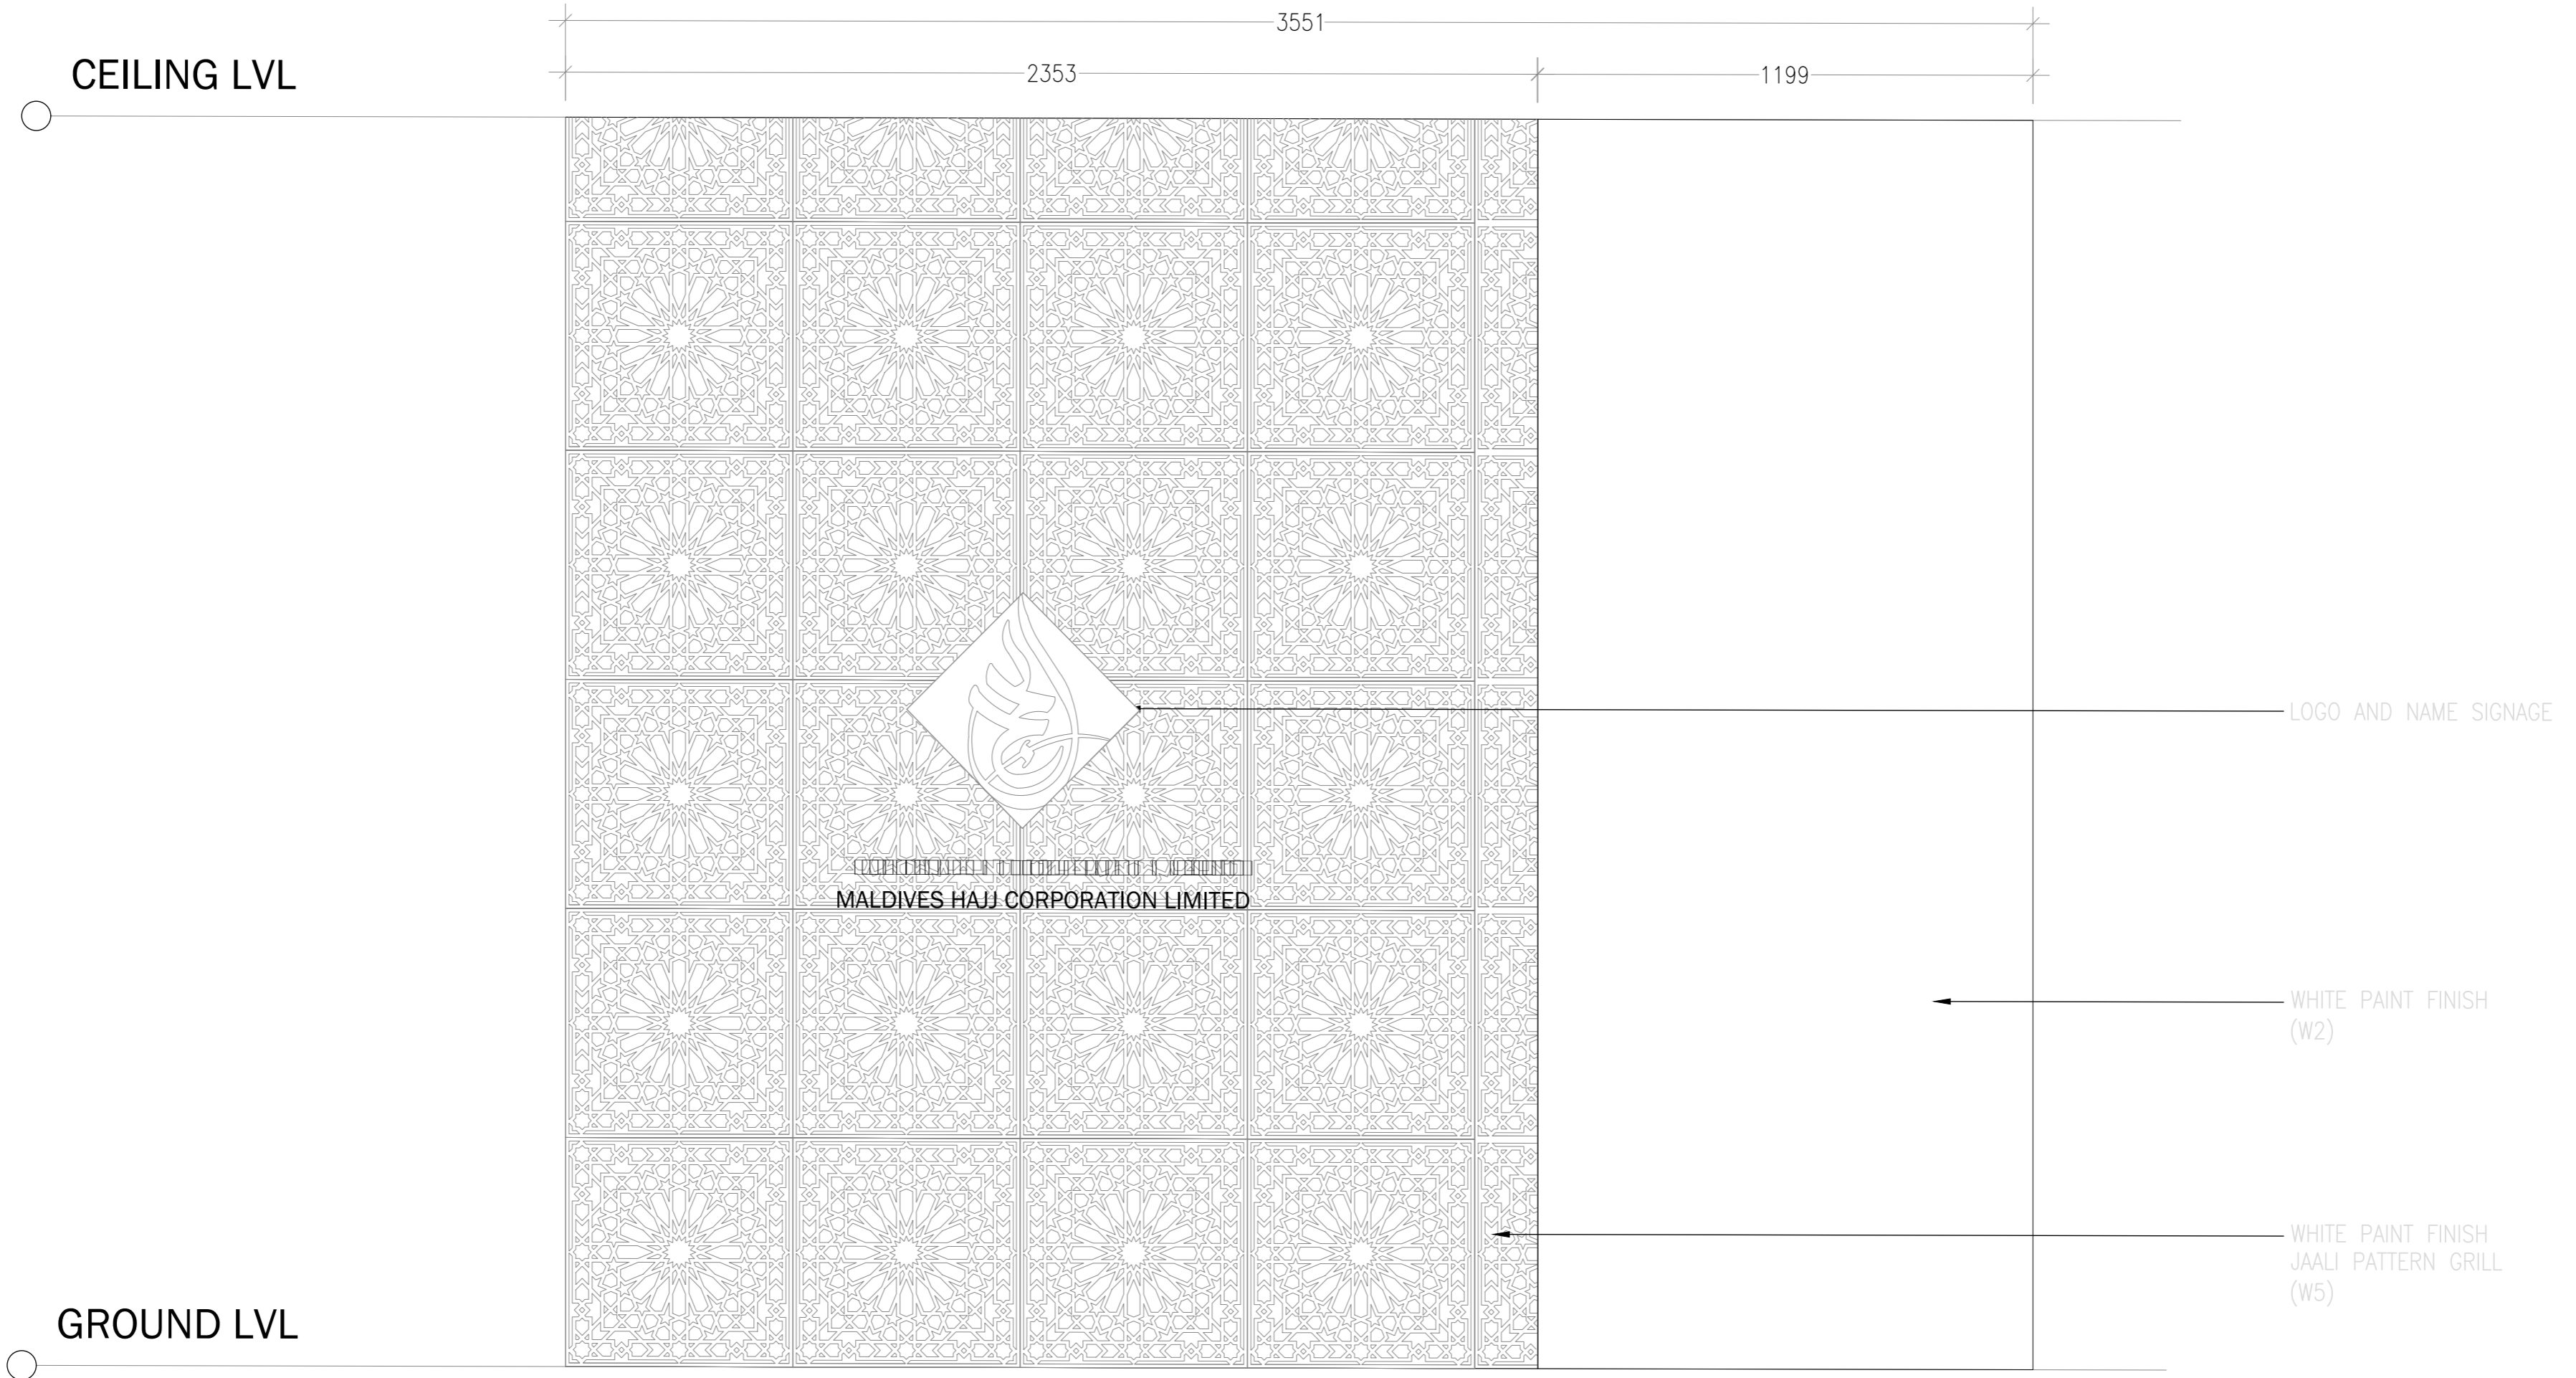


ELEVATION 01- ENTRANCE
SCALE 1:20

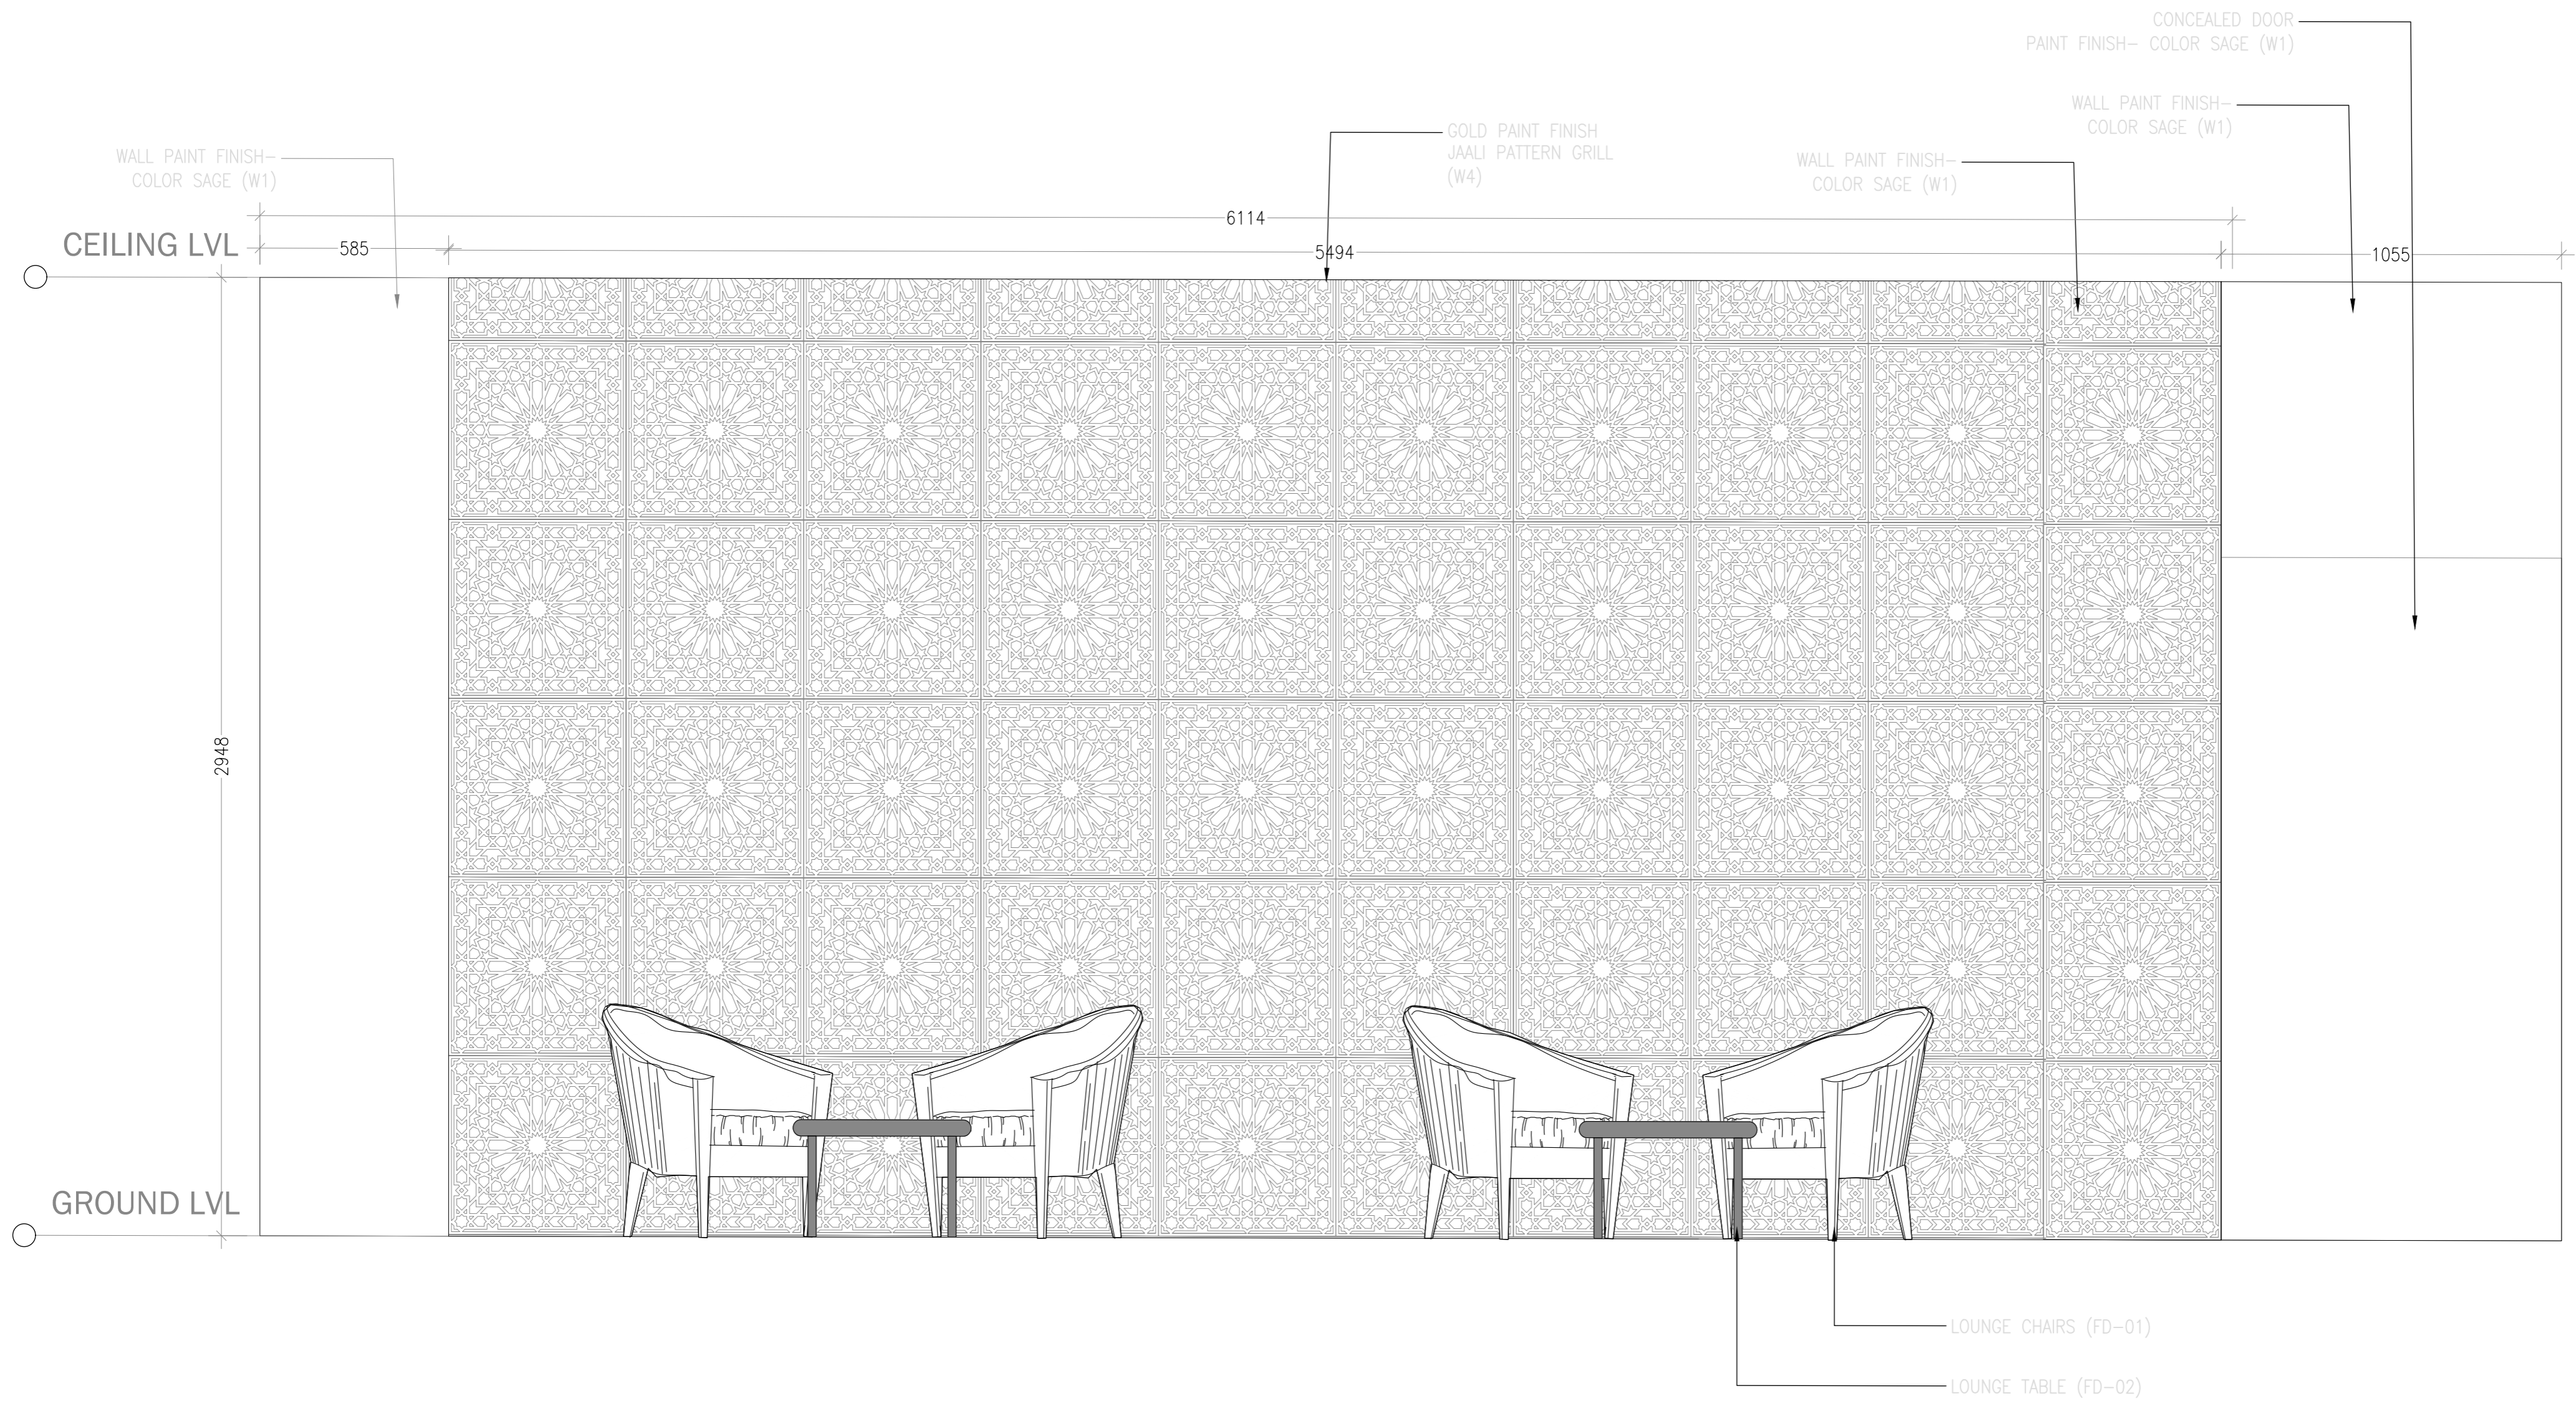


ELEVATION 02- LOUNGE
SCALE 1:20

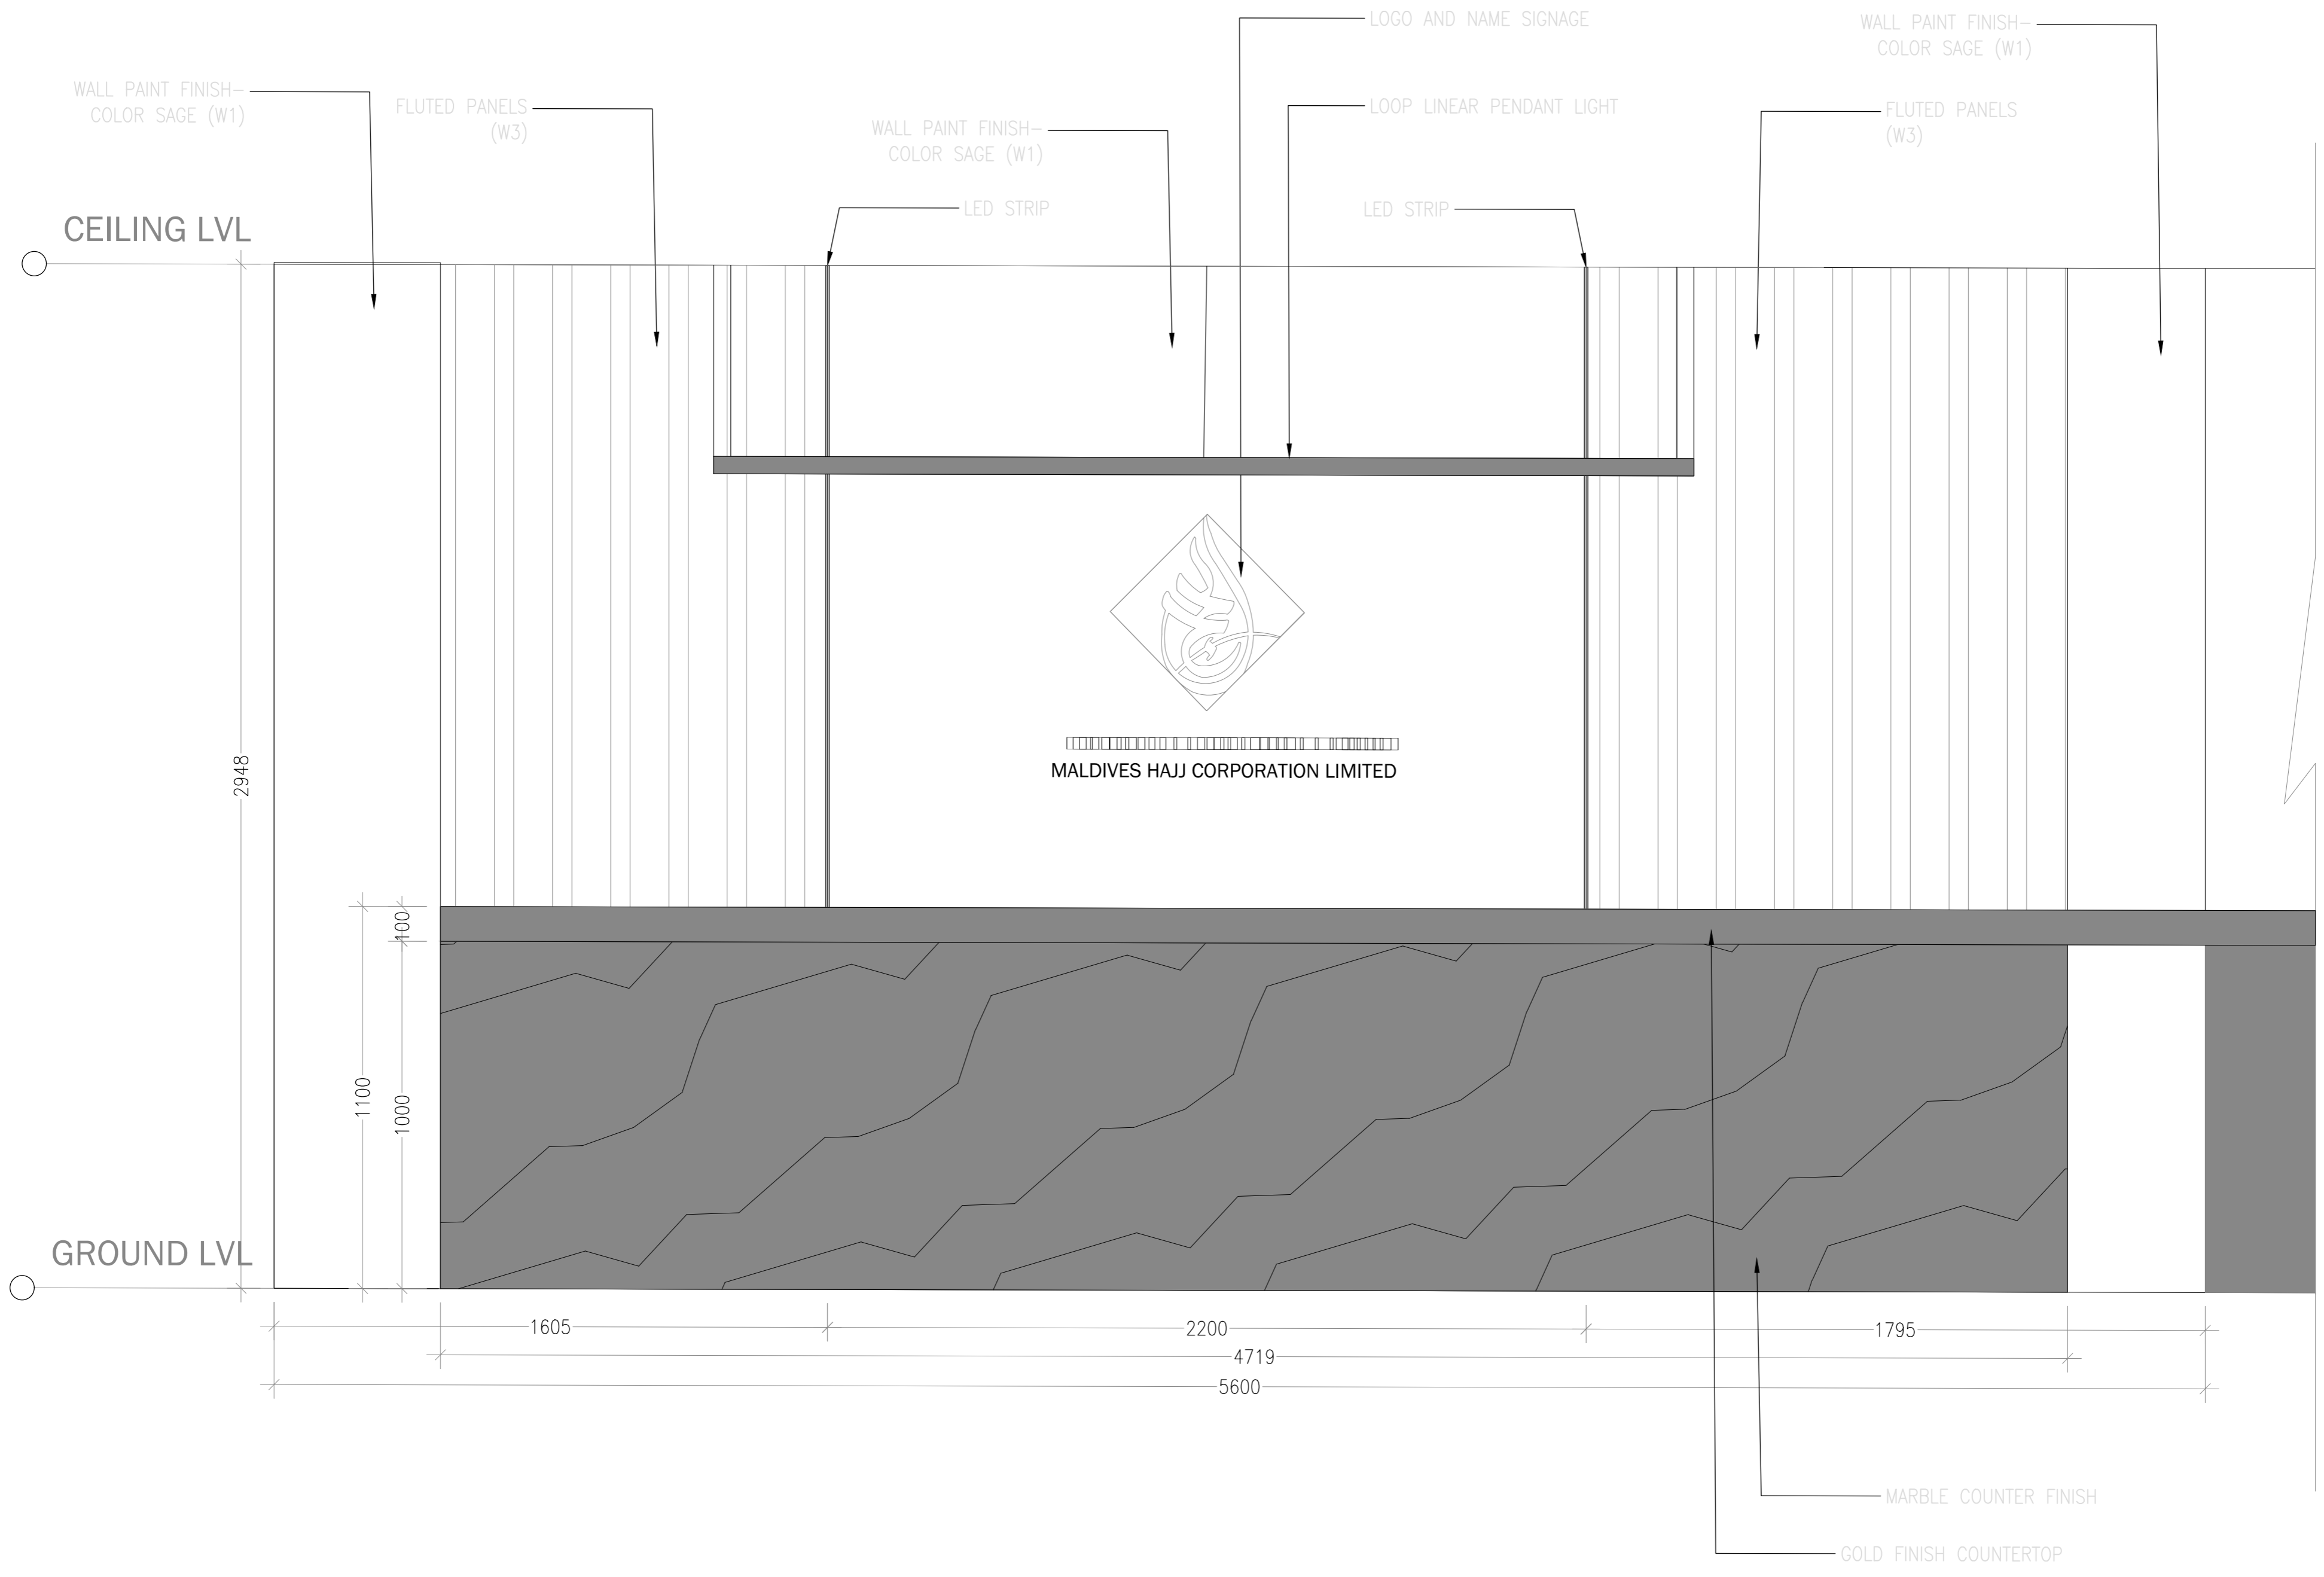


ELEVATION 03- RECEPTION
SCALE 1:20

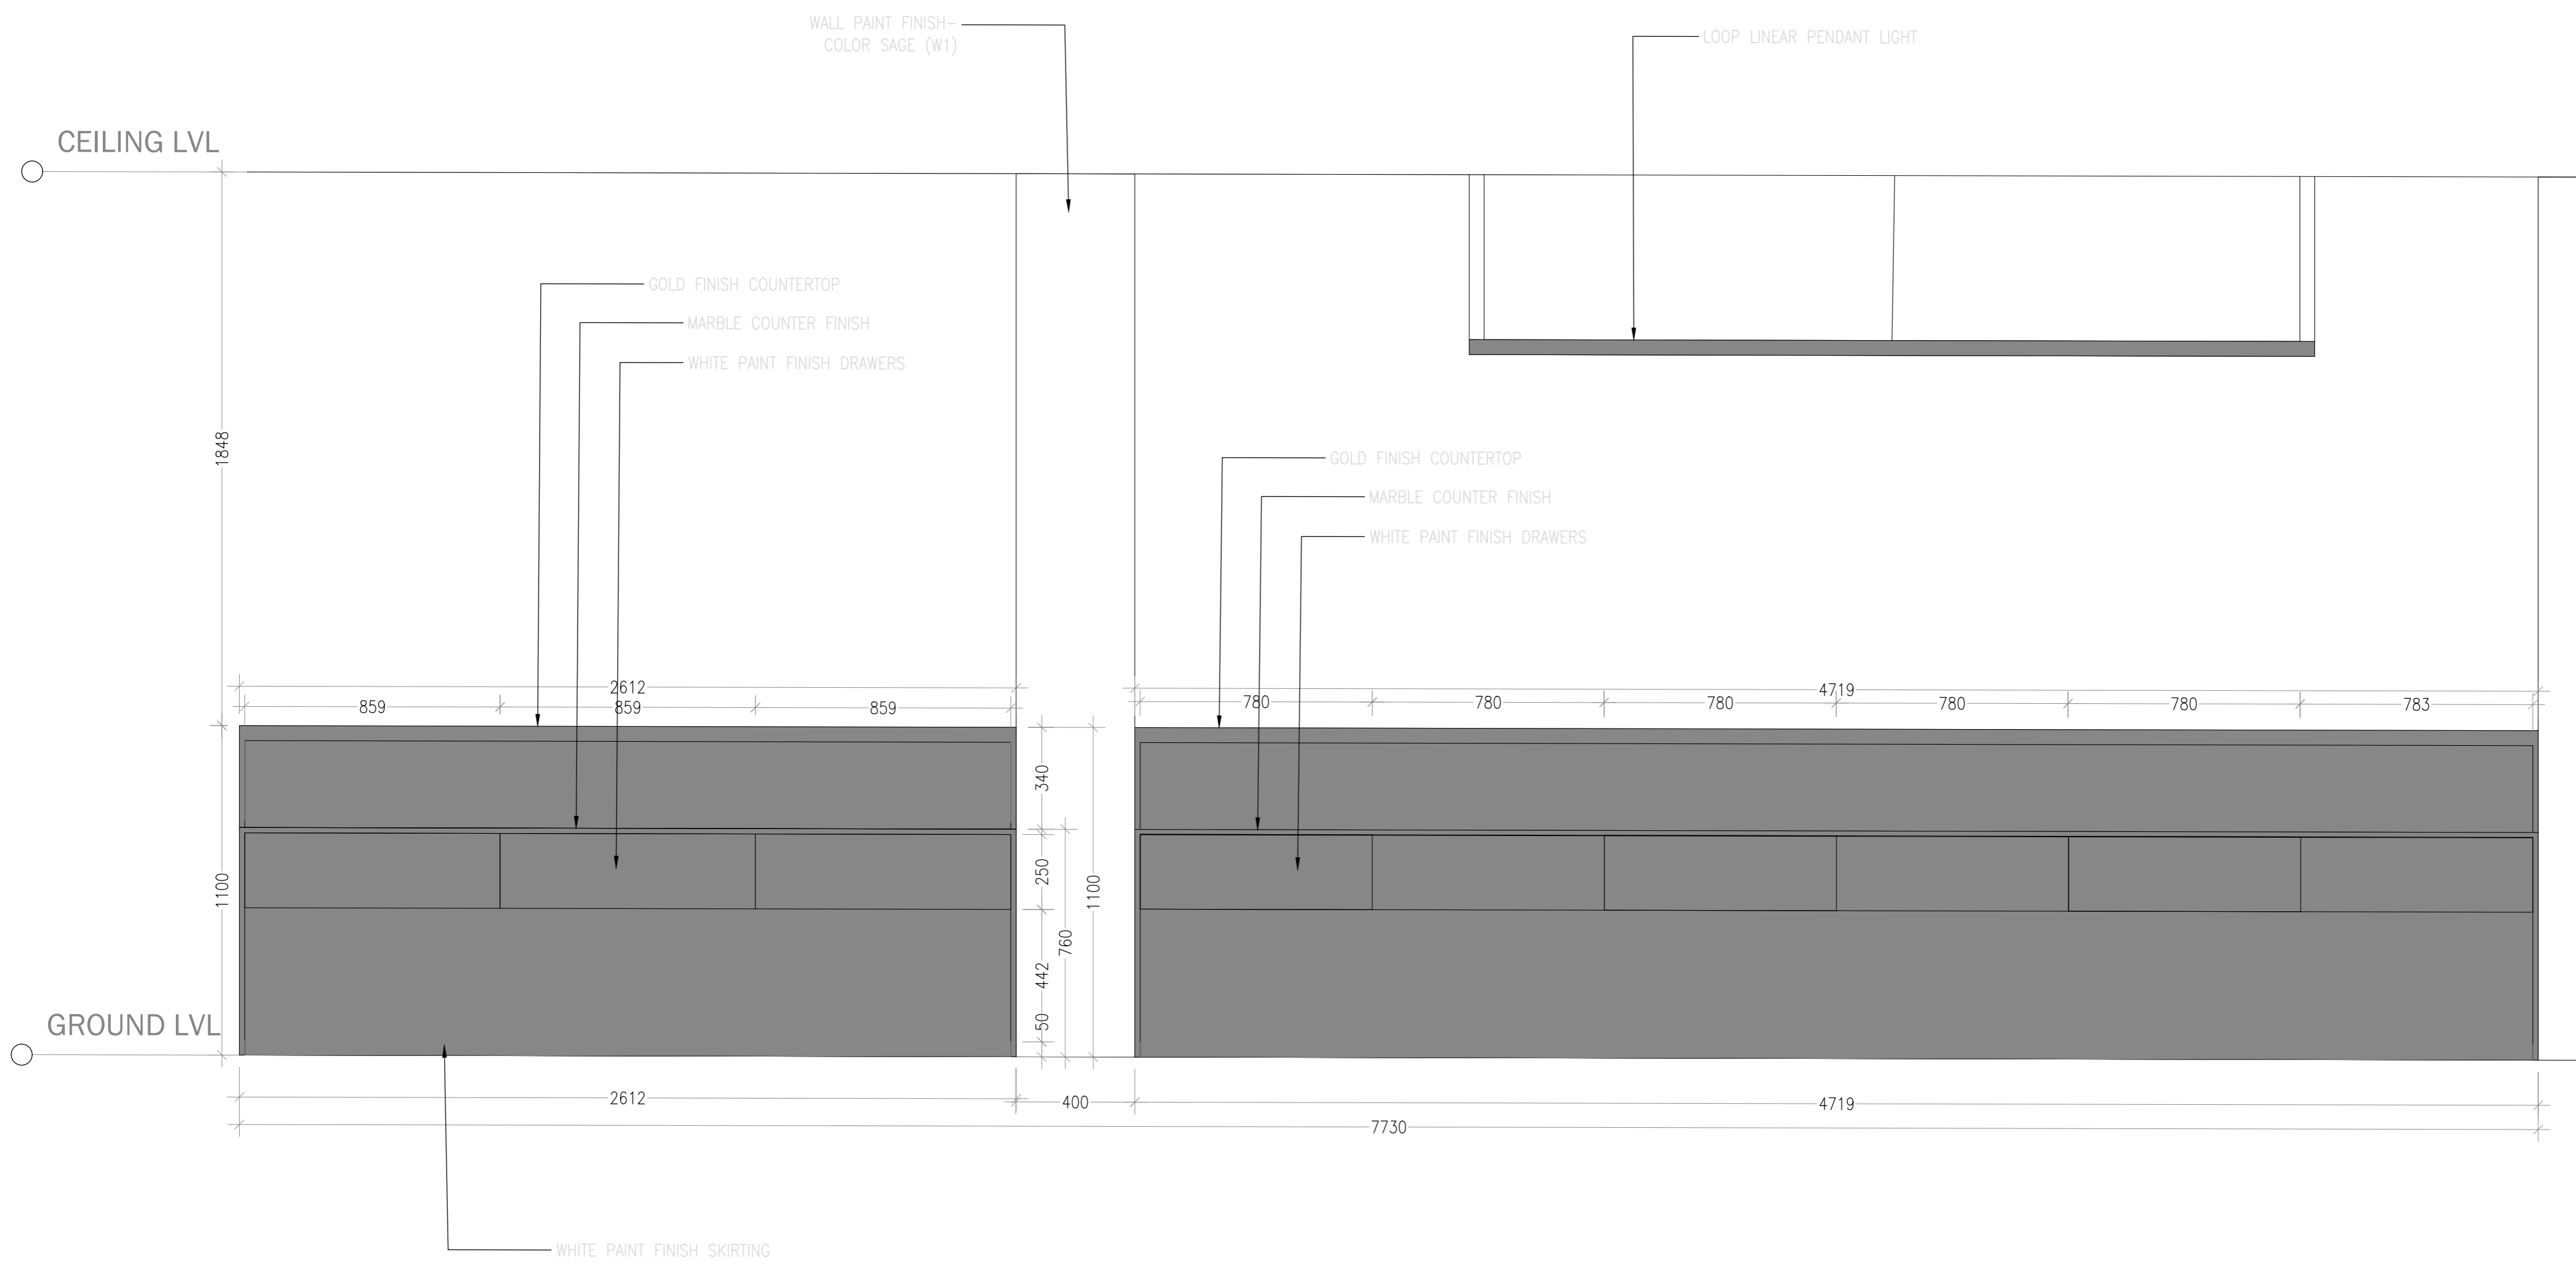

ELEVATION 04- RECEPTION
SCALE 1:20

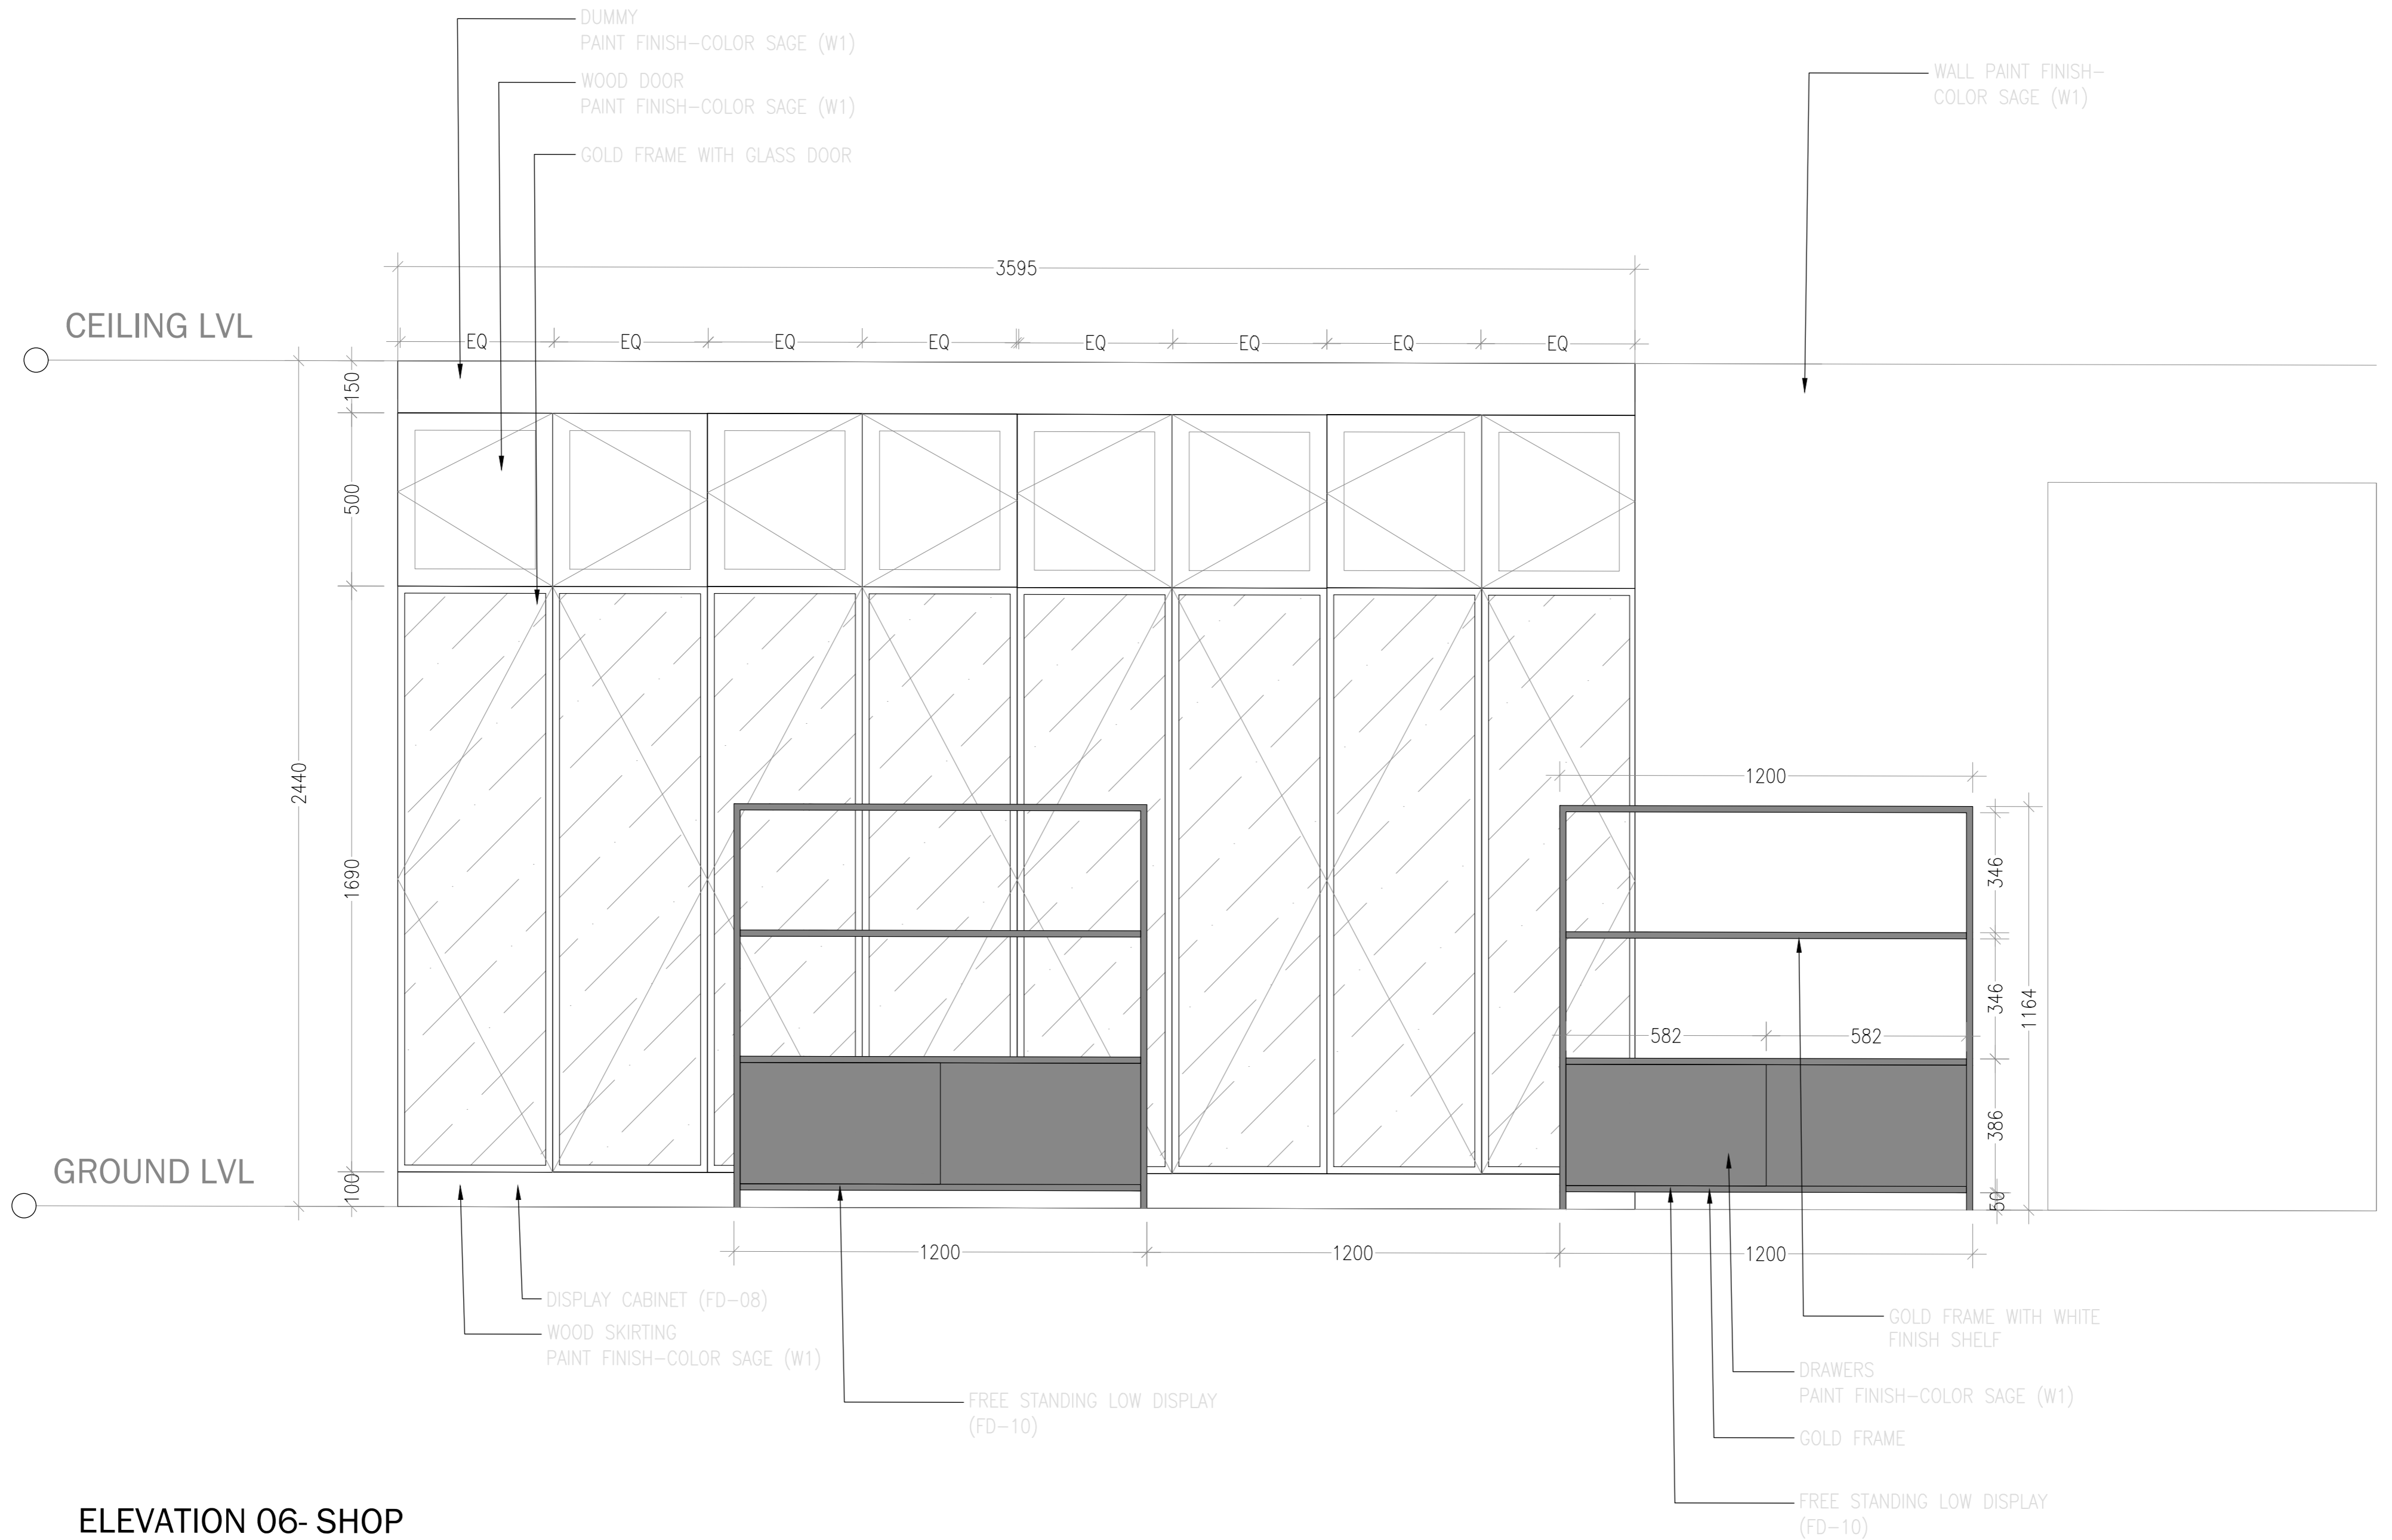

ELEVATION 06- SHOP
SCALE 1:20

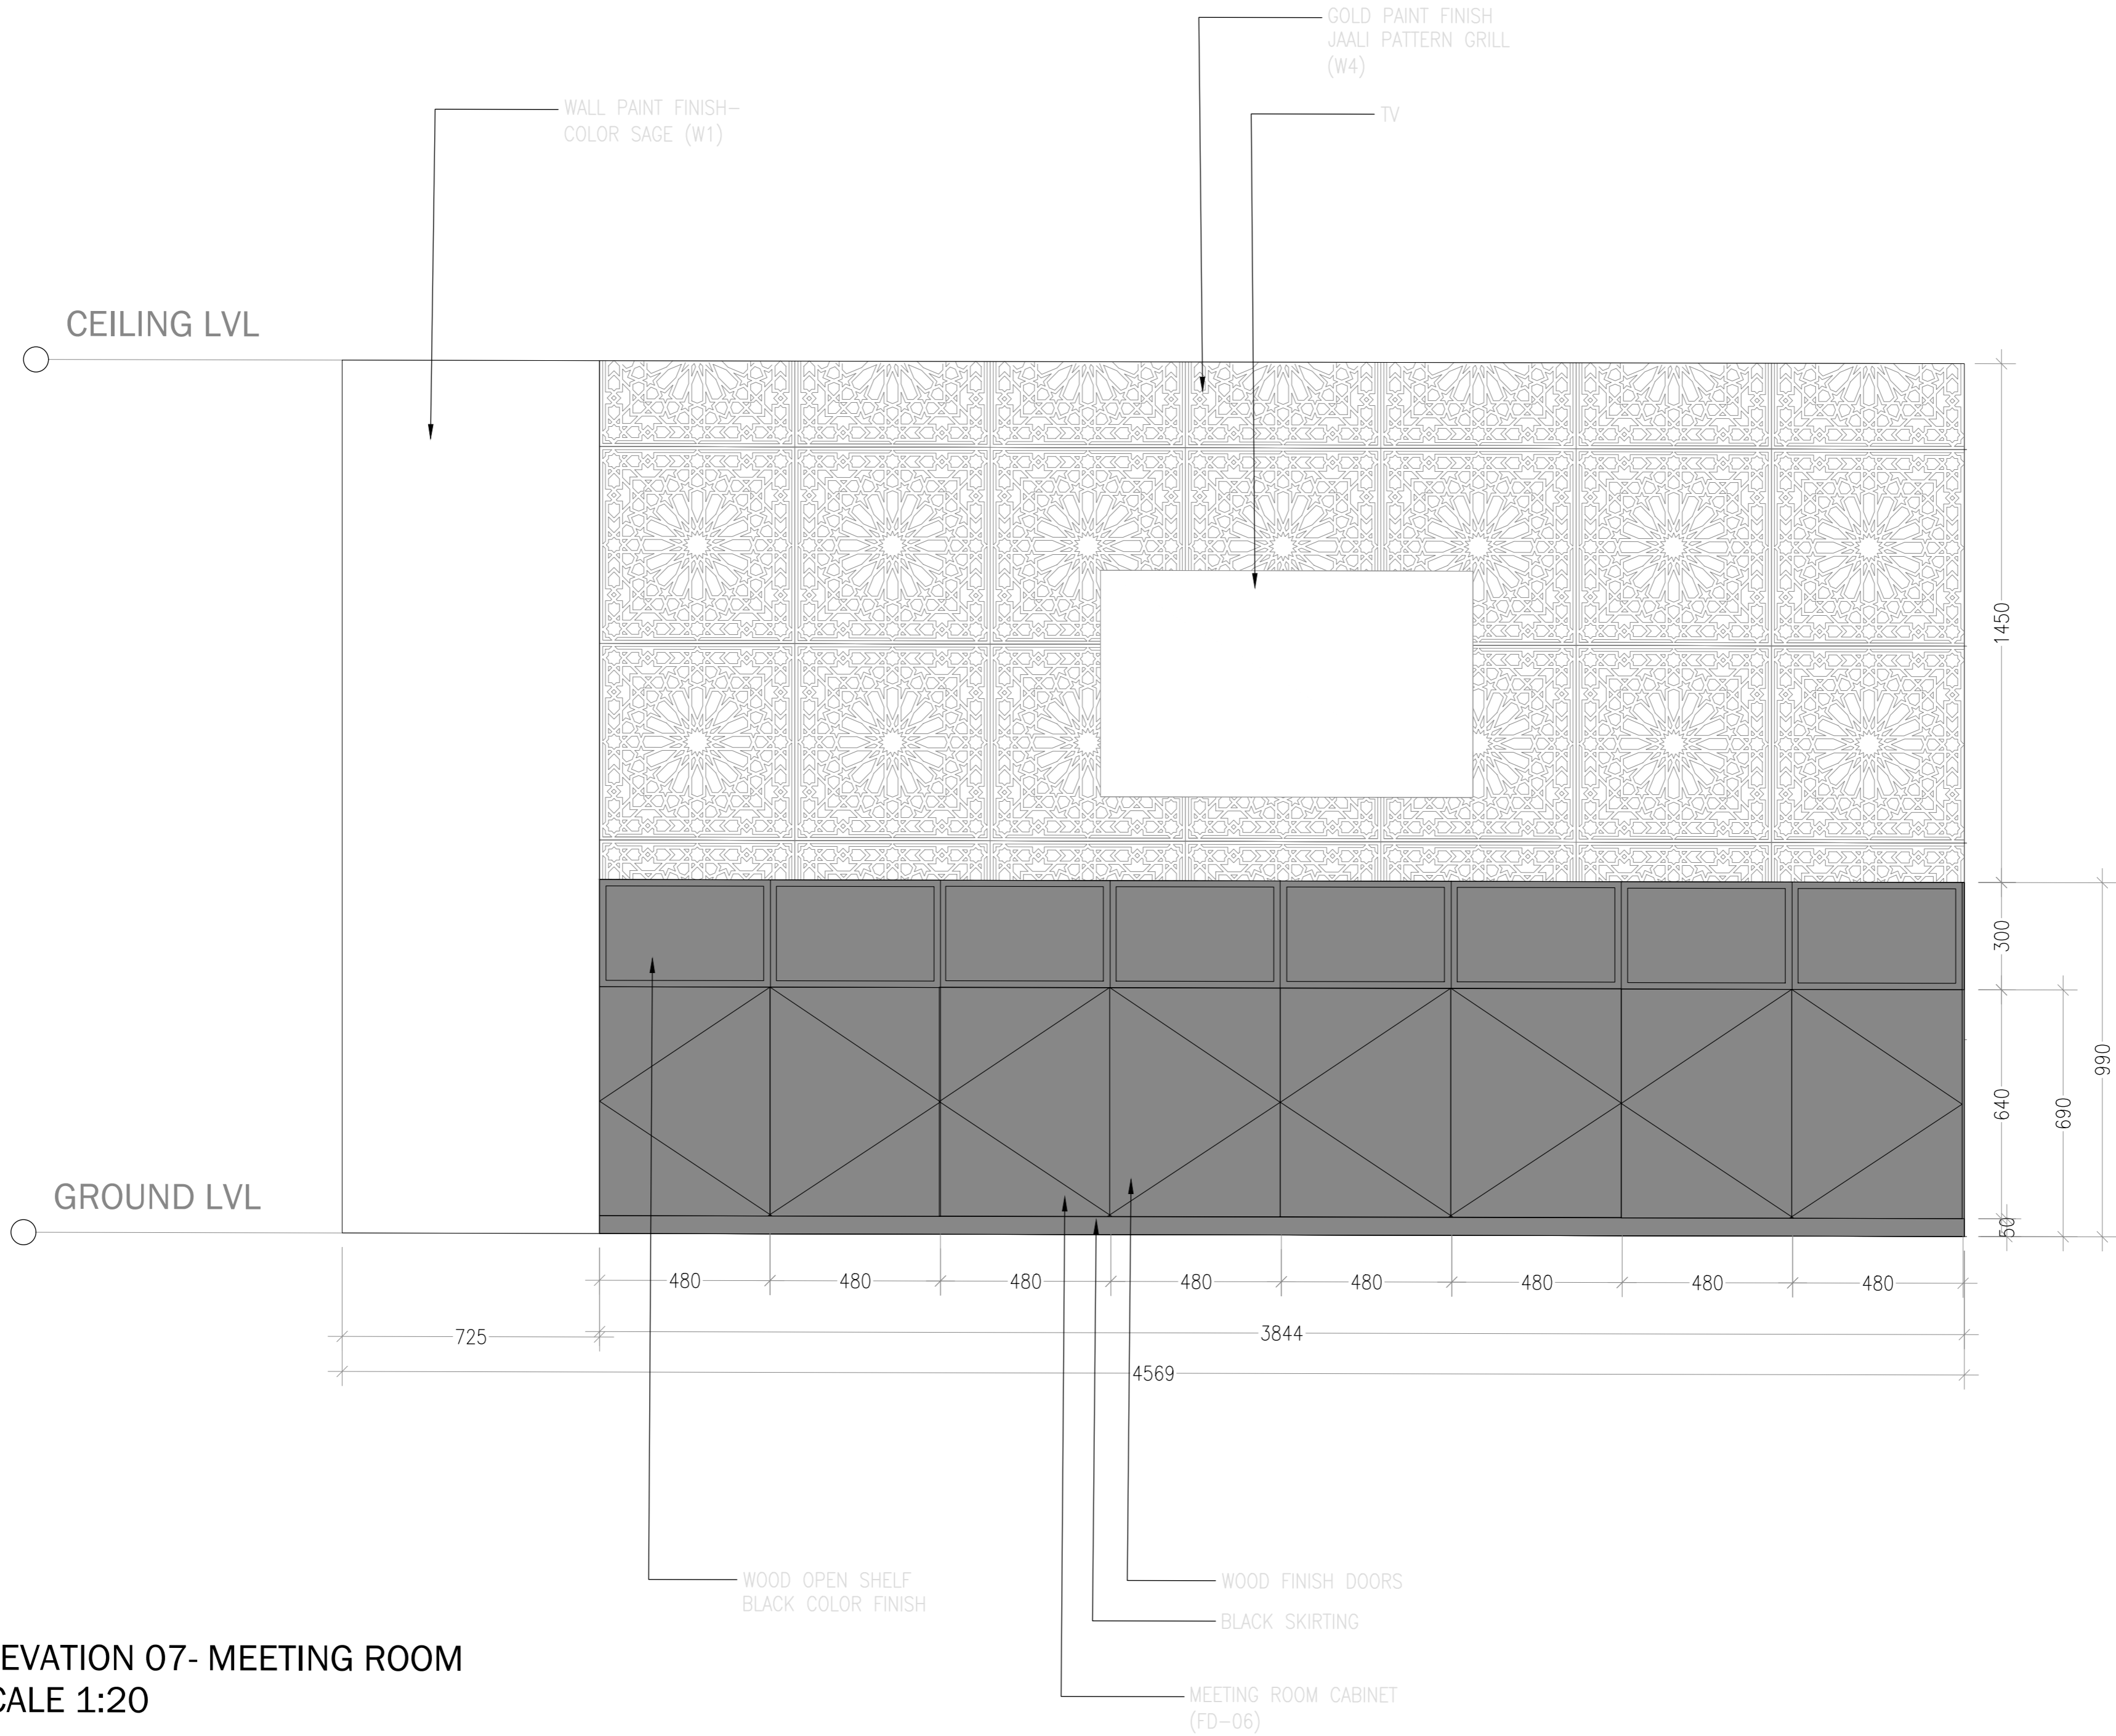

ELEVATION 07- MEETING ROOM
SCALE 1:20