


L. MAAVVAH HEALTH CENTER PORTICO AND PAVING AREA.

SCALE: 1 : 100

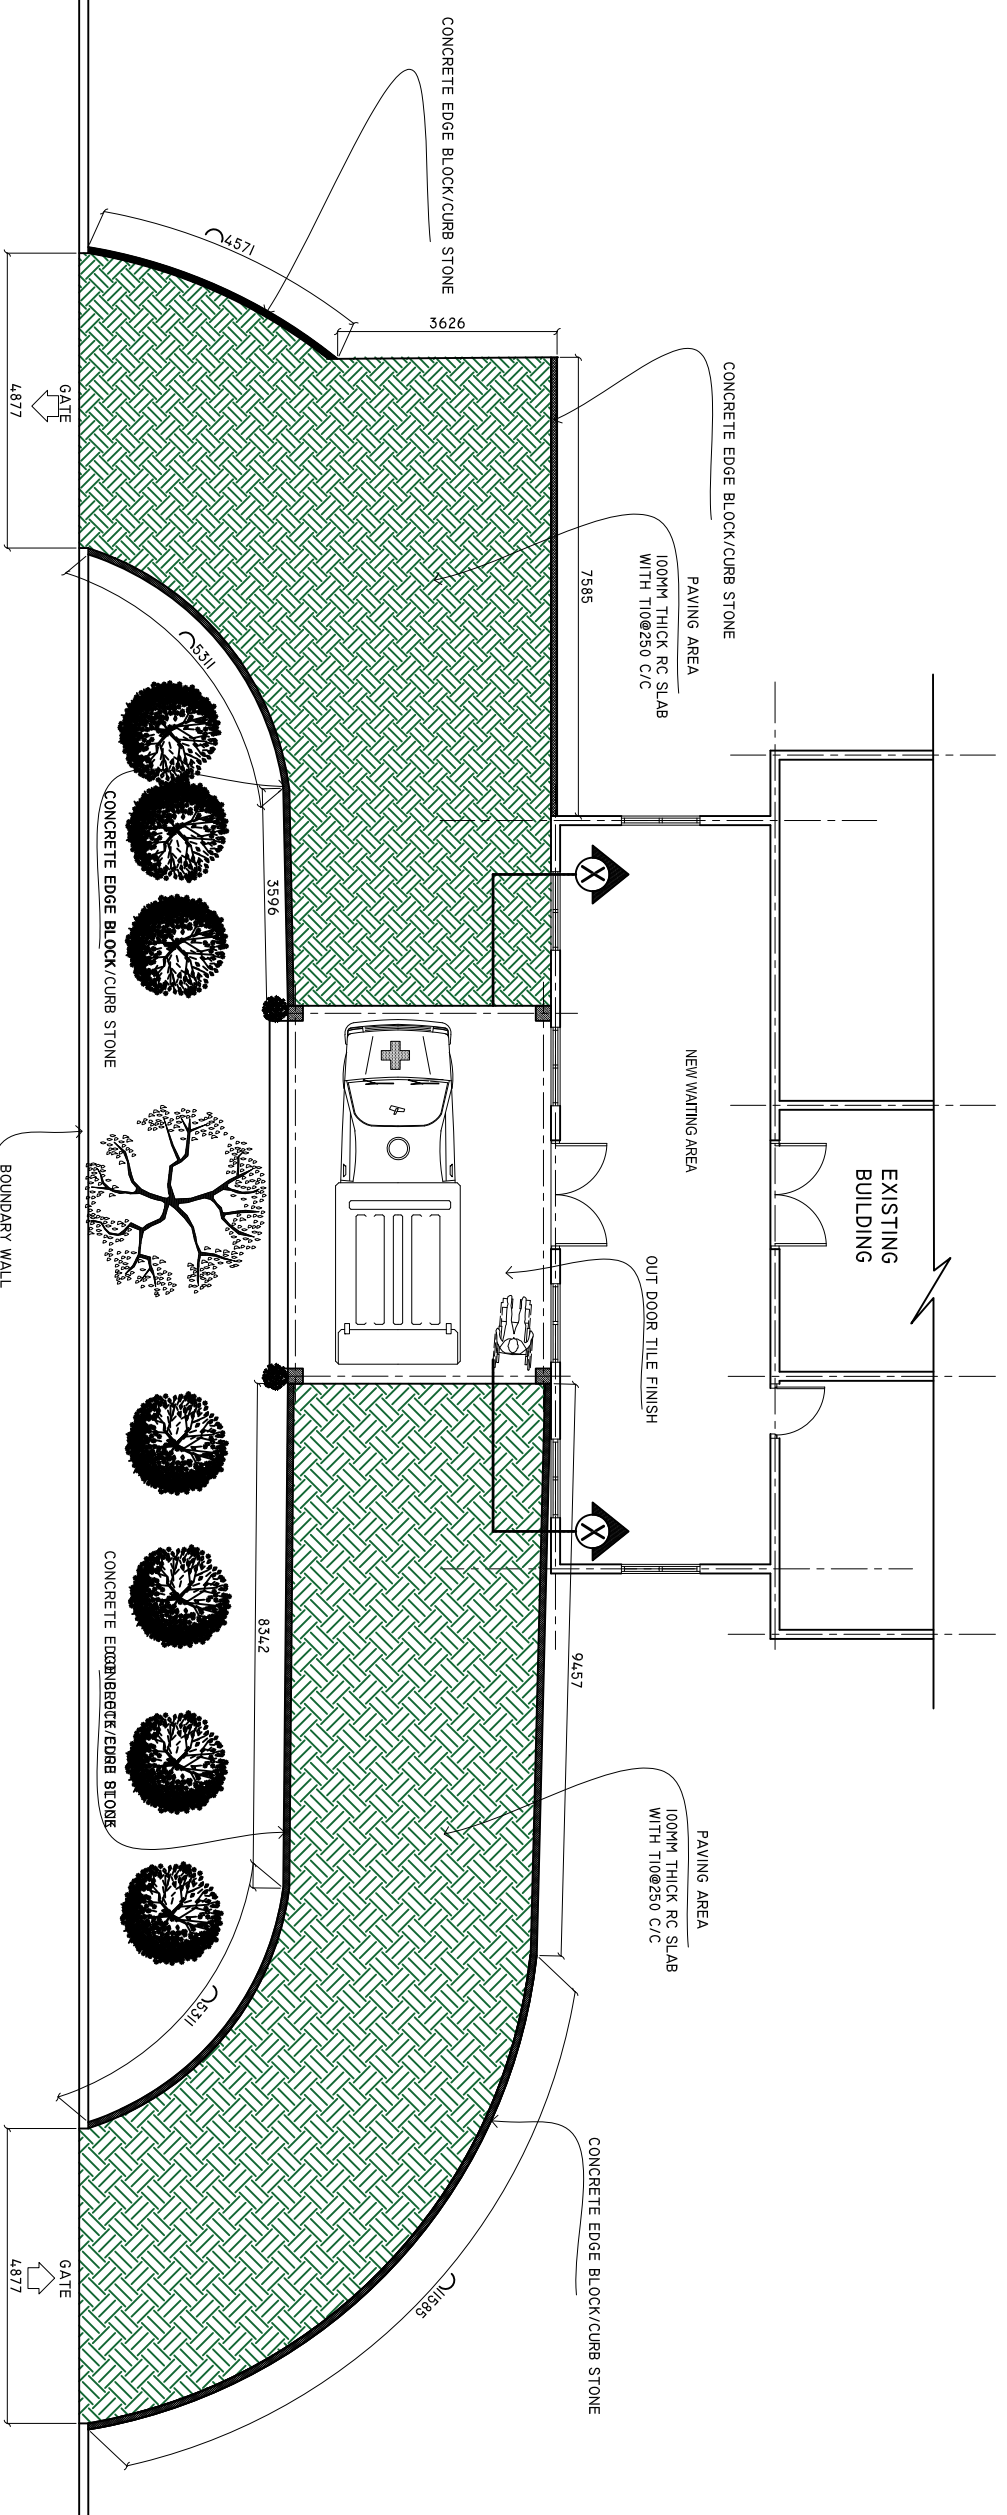

SHEET CONTENTS :

REVISION NOTES:

PROJECT:
CONSTRUCTION OF
AMBULANCE PORTICO

CLIENT:
MINISTRY OF HEALTH

LOCATION:
DIFFERENT ISLANDS

CONTENTS: AS GIVEN

PROJECT MANAGER:

DESIGNER: ARIZ

CIV/STR. ENGINEER:

SURVEYED BY: -

DRAWN BY: ARIZ

CHECKED BY:

DATE : FEBRUARY 2021


SHEET NO. : /

PAPER SIZE: A3




COLUMN AND FOOTING PLAN

SCALE: 1 : 100

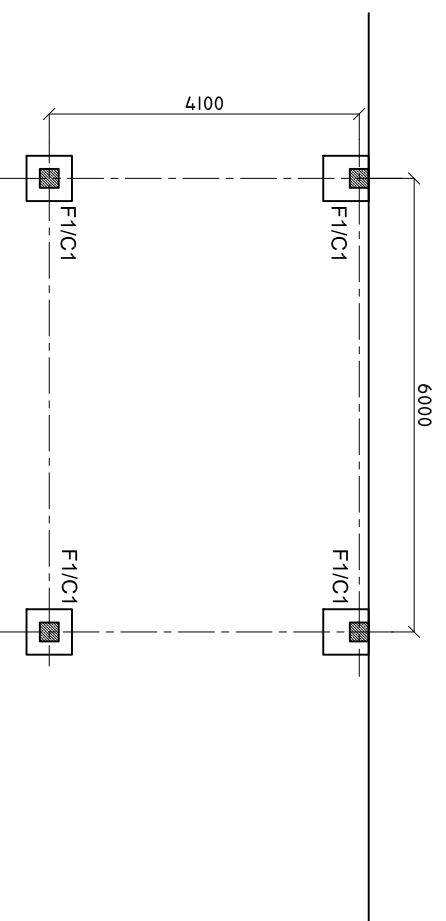


TIE BEAM PLAN

SCALE: 1 : 100

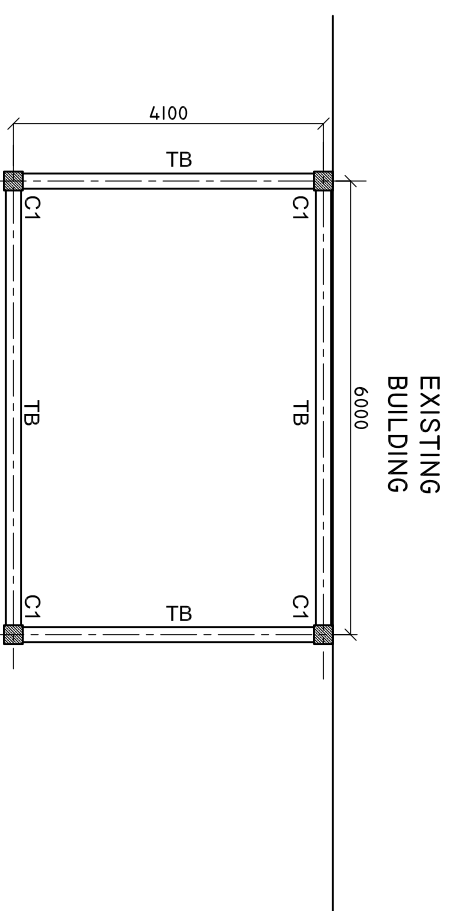


ROOF BEAM PLAN

SCALE: 1 : 100

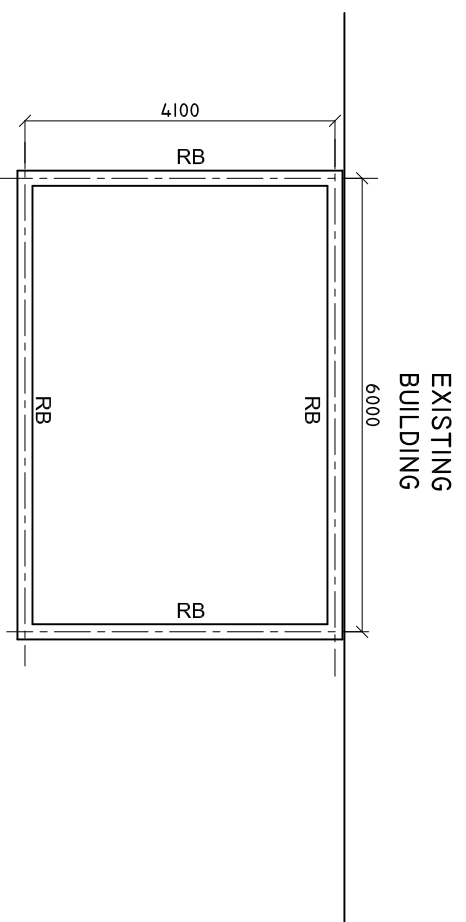

DETAILS R/C

SCALE: 1 : 25

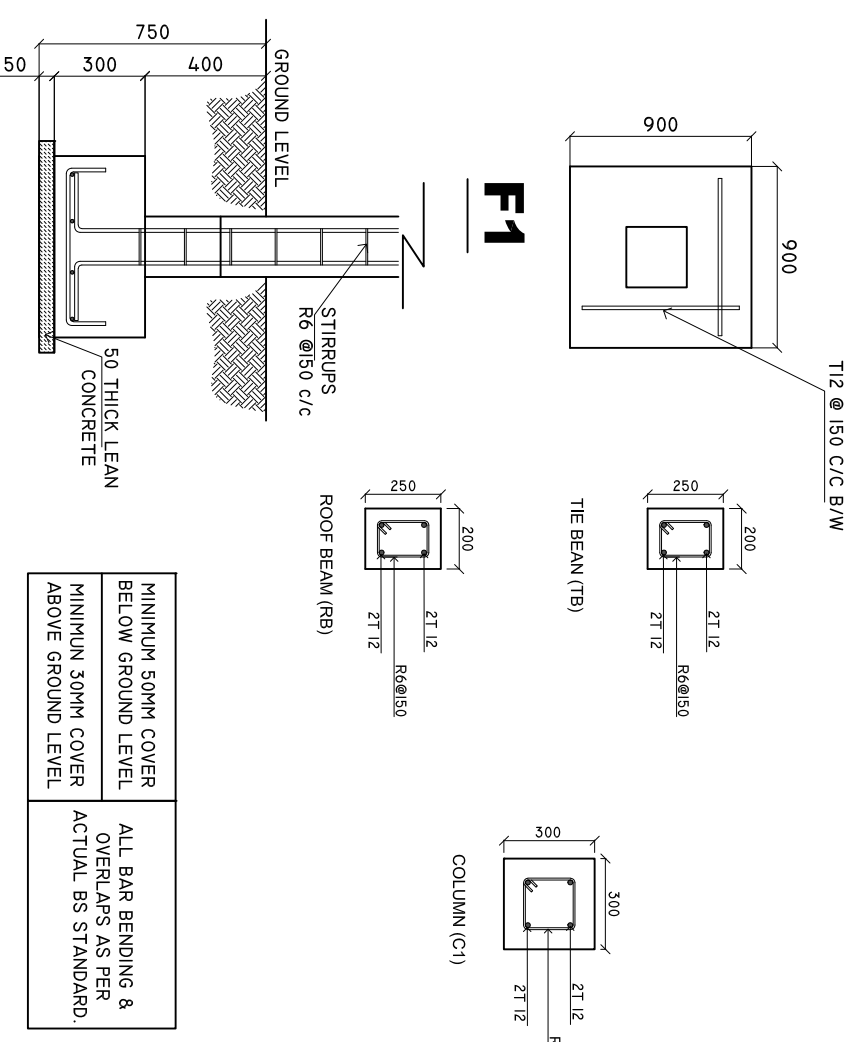

MINIMUM 50MM COVER BELOW GROUND LEVEL	ALL BAR BENDING & OVERLAPS AS PER ACTUAL BS STANDARD.
MINIMUM 30MM COVER ABOVE GROUND LEVEL	

SHEET CONTENTS :

REVISION NOTES:

PROJECT: CONSTRUCTION OF AMBULANCE PORTICO

CLIENT: MINISTRY OF HEALTH

LOCATION: DIFFERENT ISLANDS

CONTENTS: AS GIVEN

PROJECT MANAGER:

DESIGNER: ARIZ

CIV/STR. ENGINEER:

SURVEYED BY: -

DRAWN BY: ARIZ

CHECKED BY:

DATE : FEBRUARY 2021


SHEET NO. : /

PAPER SIZE: A3




ROOF PLAN

SCALE: 1 : 100

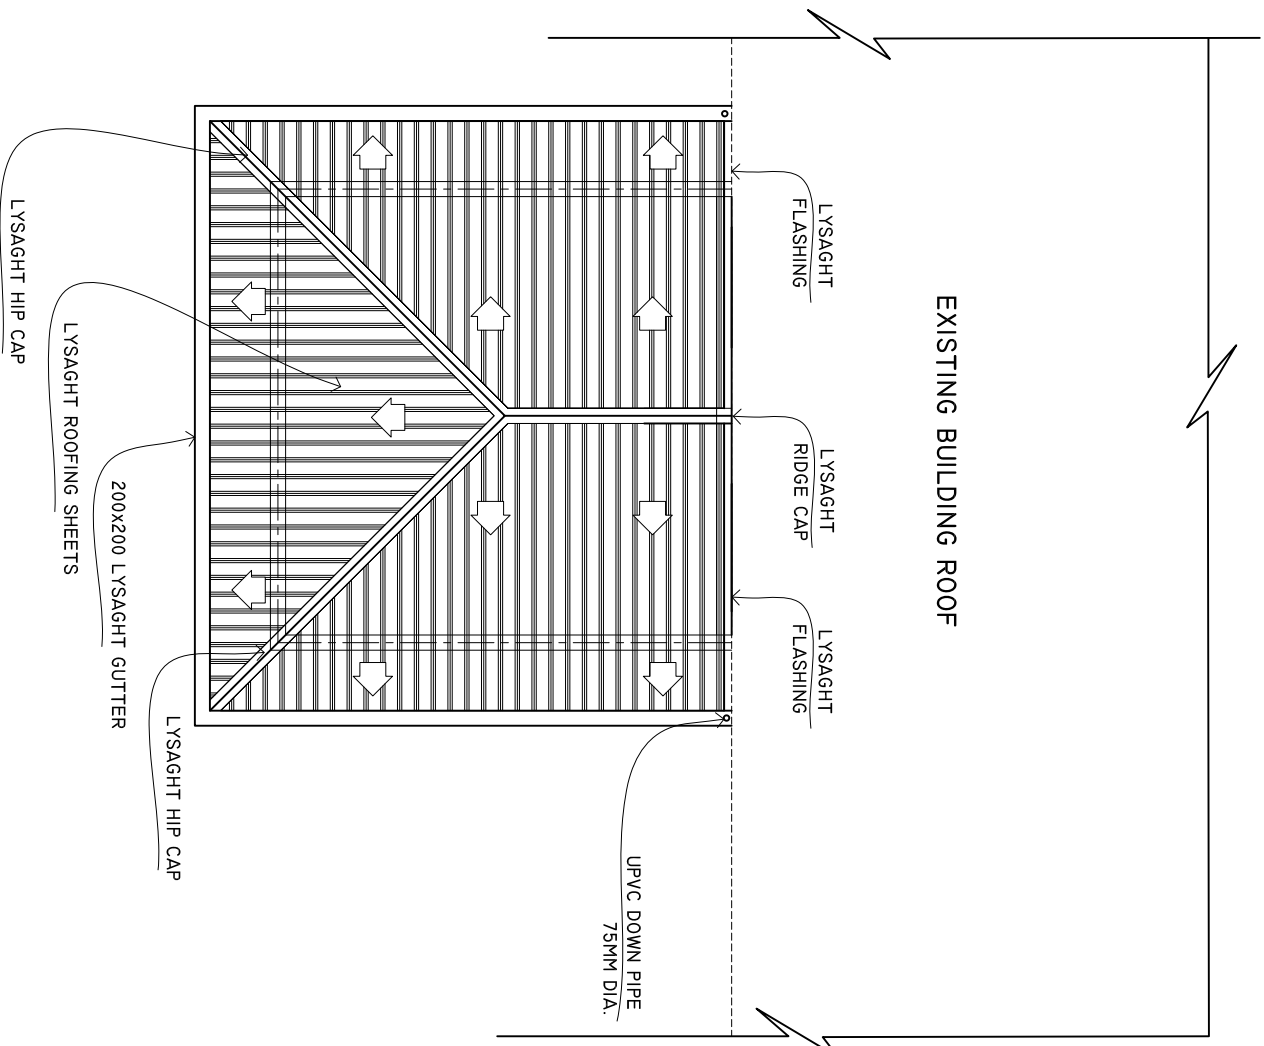

ROOF FRAMING PLAN

SCALE: 1 : 100

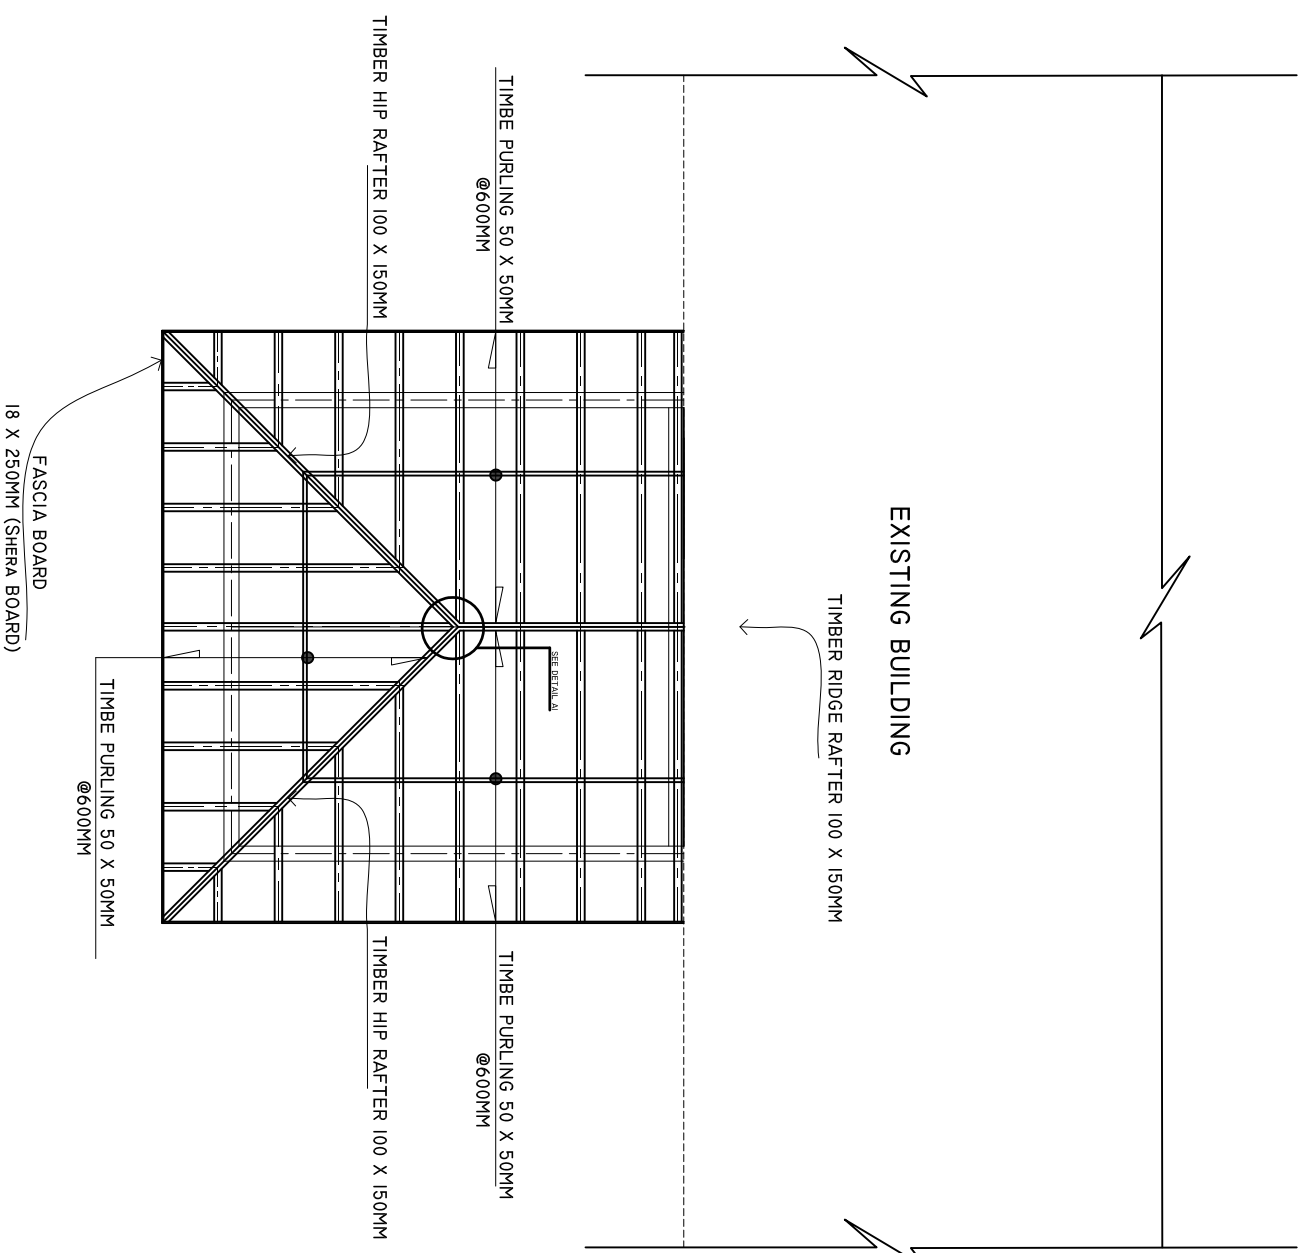

SHEET CONTENTS :

REVISION NOTES:

PROJECT:
CONSTRUCTION OF
AMBULANCE PORTICO

CLIENT:
MINISTRY OF HEALTH

LOCATION:
DIFFERENT ISLANDS


CONTENTS: AS GIVEN

PROJECT MANAGER:
DESIGNER: ARIZ
CIV/STR. ENGINEER:
SURVEYED BY: -
DRAWN BY: ARIZ
CHECKED BY:
DATE : FEBRUARY 2021
SHEET NO. : /
PAPER SIZE: A3




FRONT ELEVATION

SCALE: 1 : 50

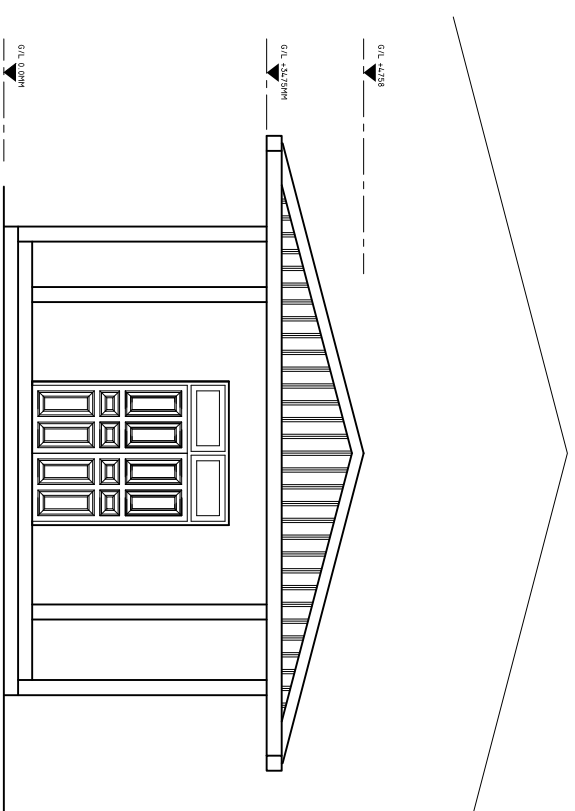


SIDE ELEVATION

SCALE: 1 : 50

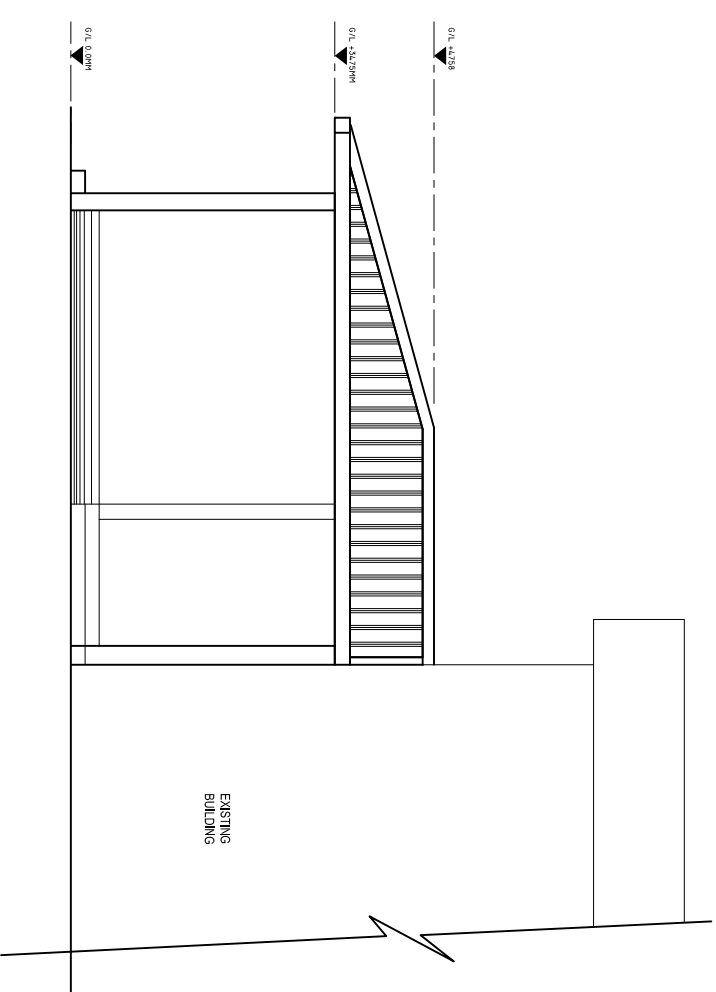

ELECTRICAL LAYOUT

SCALE: 1 : 100

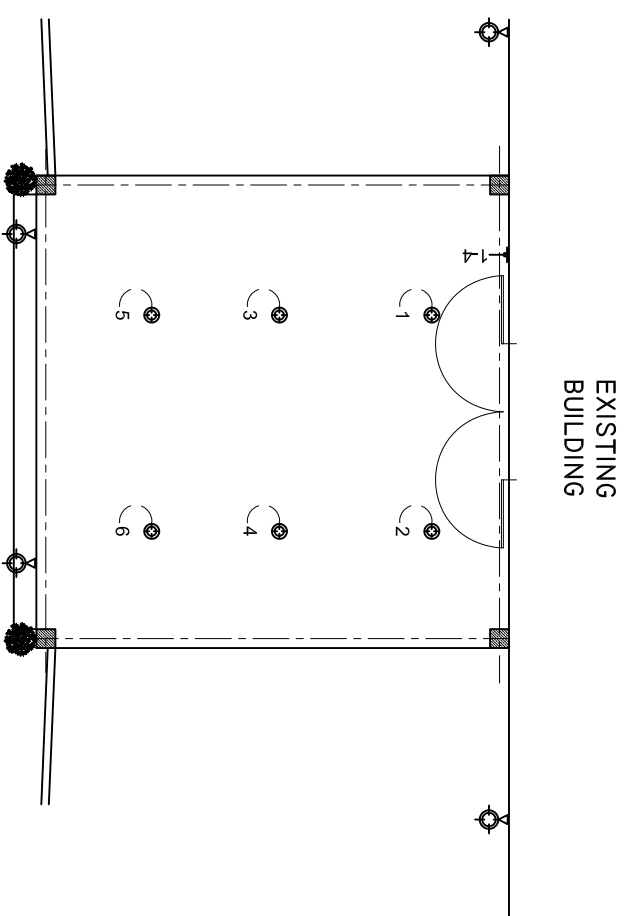

LEGEND

SYMBOL	DESCRIPTION
	OUR DOOR WHETHER PROOF LIGHT 21W PHILIPS.
	OUTDOOR WHETHER PROOF LIGHT 21W PHILIPS.

SHEET CONTENTS :

REVISION NOTES:

PROJECT:

CONSTRUCTION OF
AMBULANCE PORTICO

CLIENT:

MINISTRY OF HEALTH

LOCATION:

DIFFERENT ISLANDS

CONTENTS: AS GIVEN

PROJECT MANAGER:

DESIGNER: ARIZ

CIV/STR. ENGINEER:

SURVEYED BY: -

DRAWN BY: ARIZ

CHECKED BY:

DATE : FEBRUARY 2021

SHEET NO. : /


PAPER SIZE: A3



ADMIN DIVISON
Ministry of Health
Roshanee Building
Sosun Magsi
Tel: 332 8887, Fax: 3328889


DETAIL B

SCALE: 1 : 10

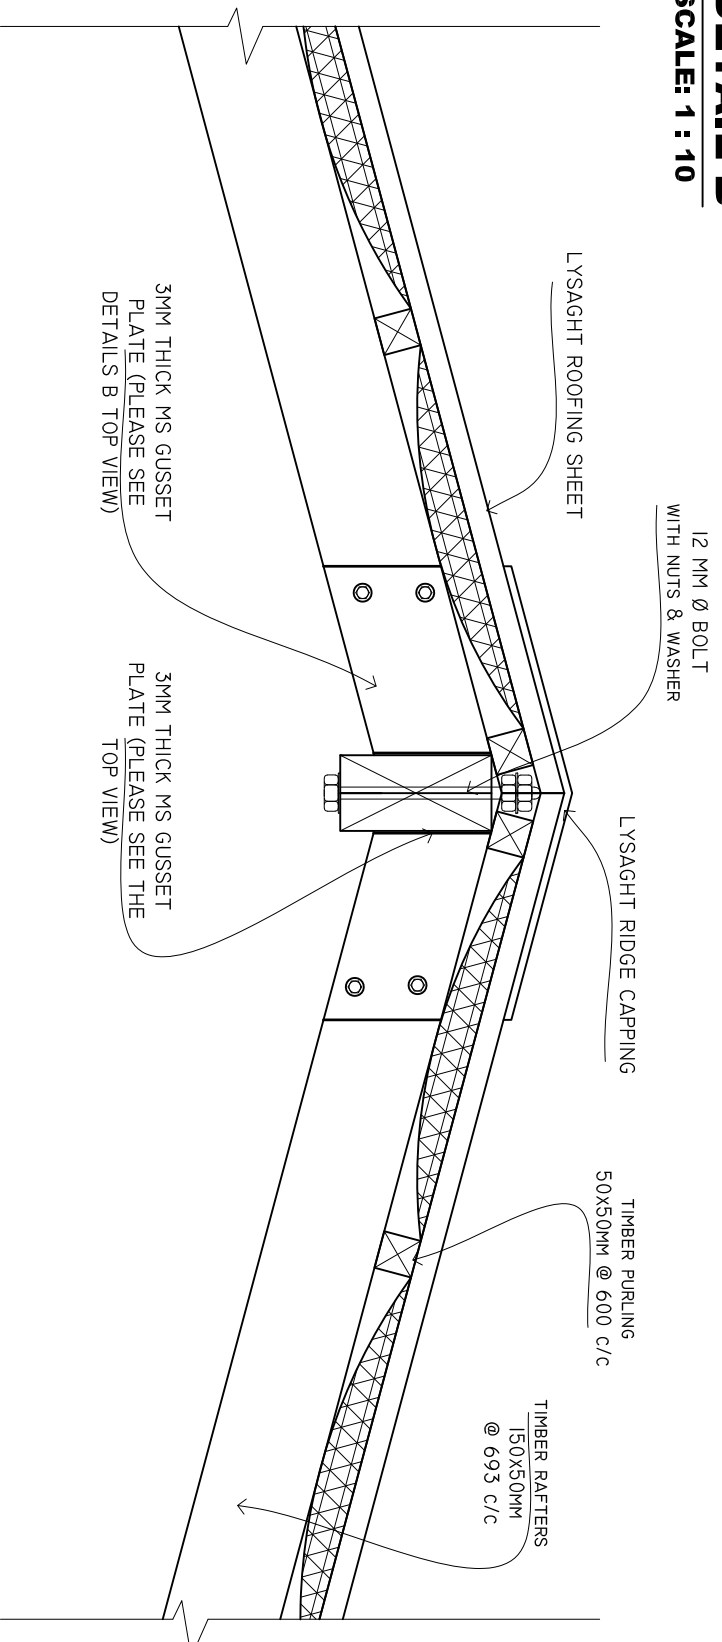

DETAILS B (TOP VIEW)

SCALE: 1 : 10

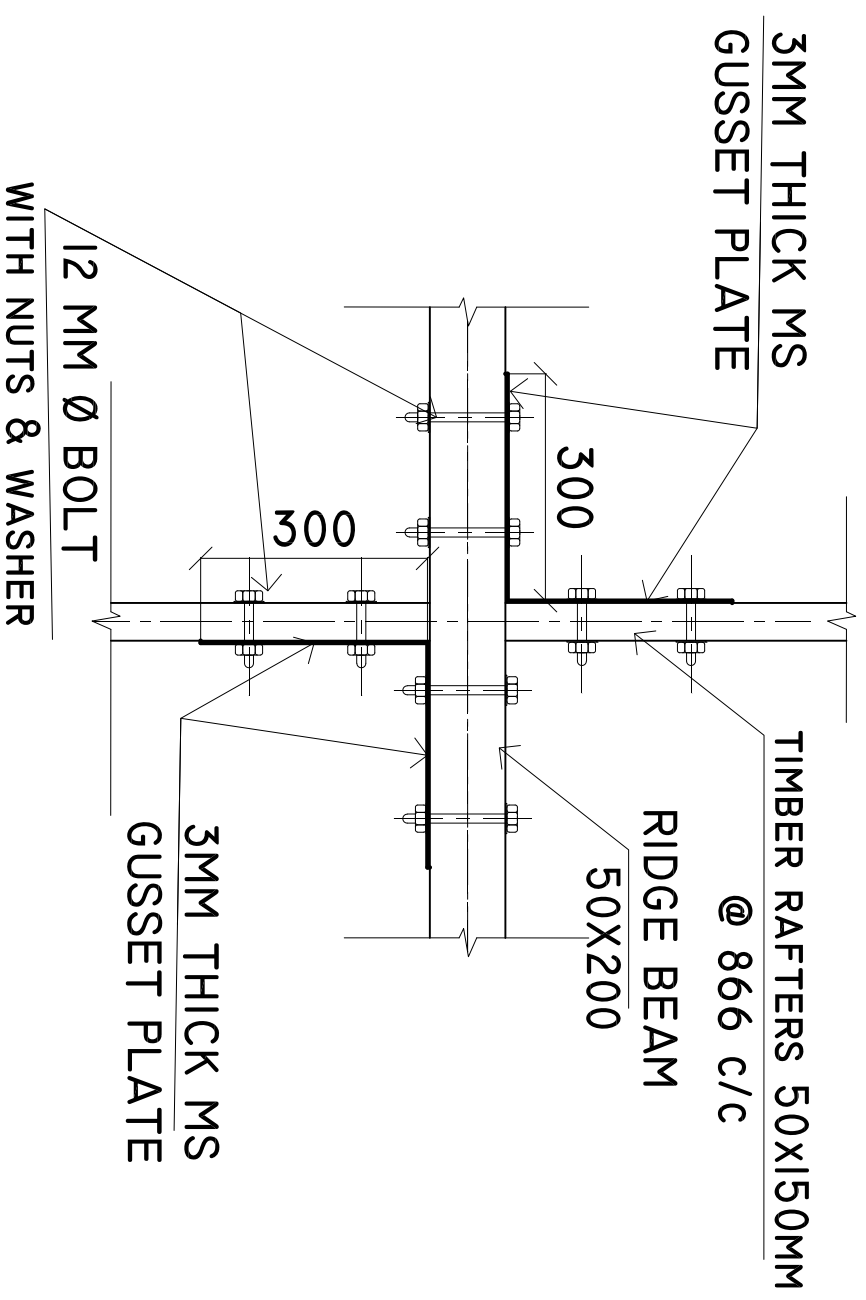

SHEET CONTENTS :

REVISION NOTES:

PROJECT:
CONSTRUCTION OF
AMBULANCE PORTICO

CLIENT:
MINISTRY OF HEALTH

LOCATION:
DIFFERENT ISLANDS

CONTENTS: AS GIVEN

PROJECT MANAGER:

DESIGNER: ARIZ

CIV/STR. ENGINEER:

SURVEYED BY: -

DRAWN BY: ARIZ

CHECKED BY:

DATE : FEBRUARY 2021


SHEET NO. : /

PAPER SIZE: A3



DETAIL A

SCALE: 1 : 10

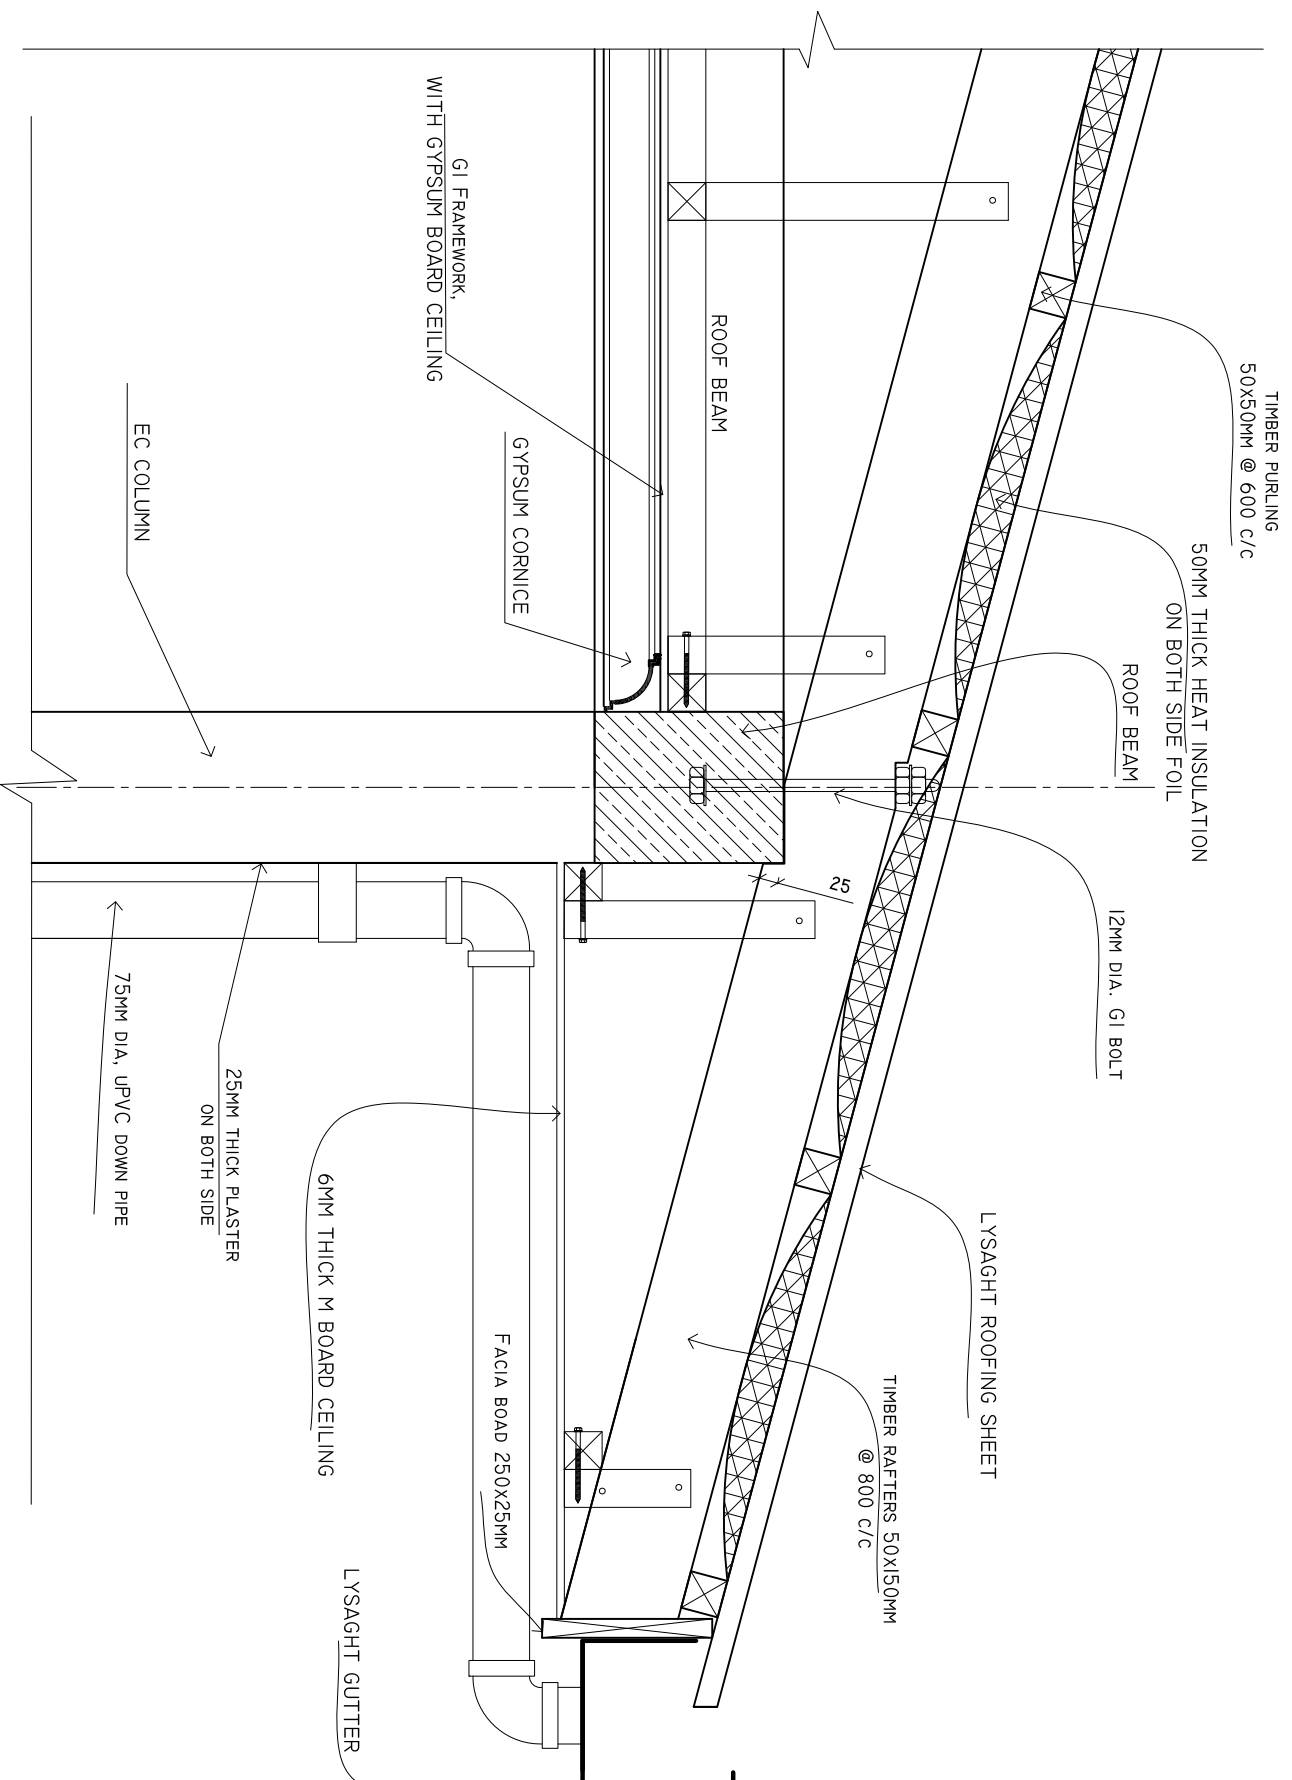

SHEET CONTENTS :

REVISION NOTES:

PROJECT:
CONSTRUCTION OF
AMBULANCE PORTICO

CLIENT:
MINISTRY OF HEALTH

LOCATION:
DIFFERENT ISLANDS

CONTENTS: AS GIVEN

PROJECT MANAGER:

DESIGNER: ARIZ

CIV/STR. ENGINEER:

SURVEYED BY: -

DRAWN BY: ARIZ

CHECKED BY:

DATE : FEBRUARY 2021


SHEET NO. : /

PAPER SIZE: A3




DETAILS A1

SCALE: 1 : 10

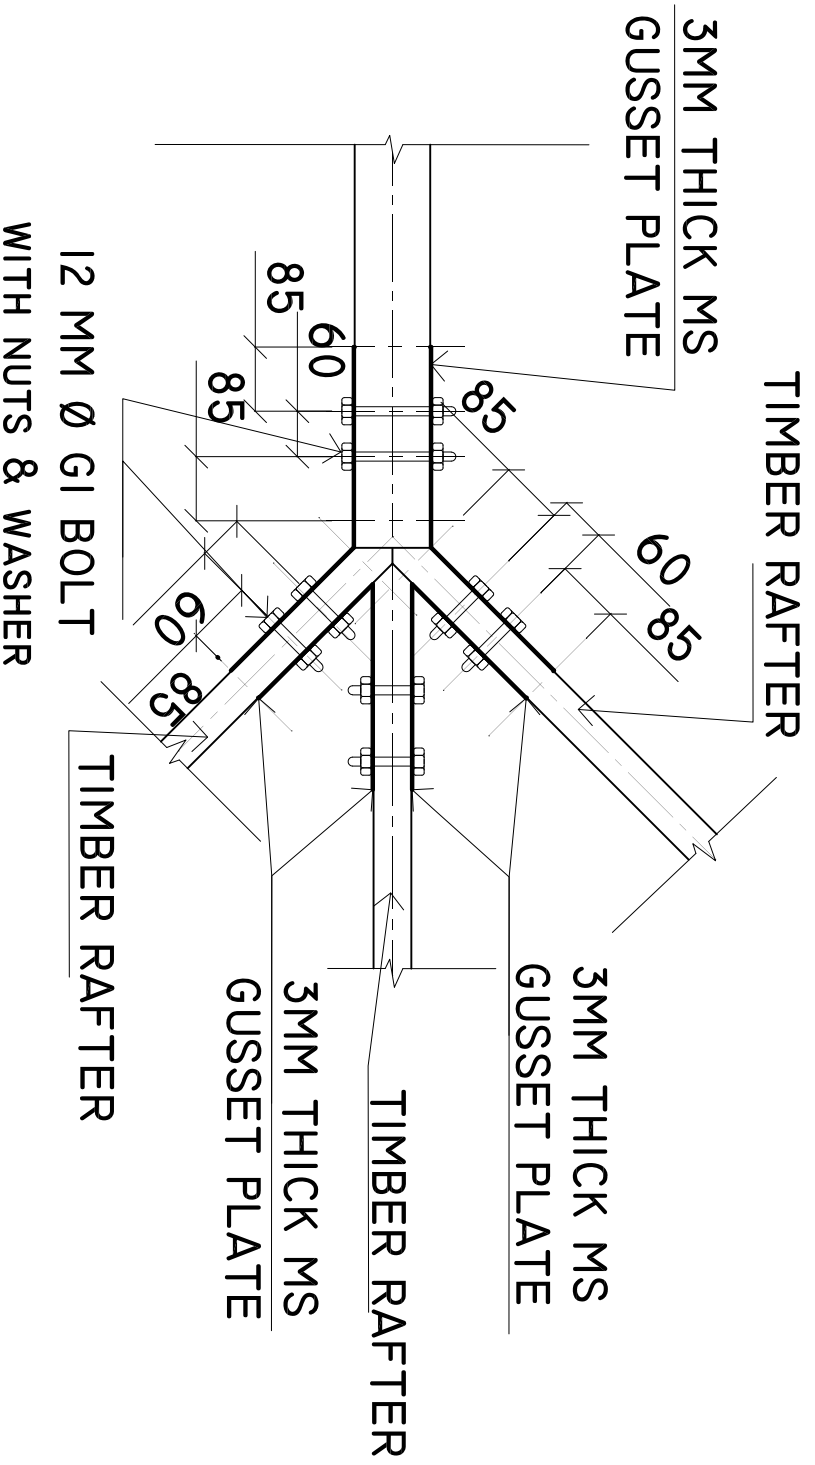

HIP RAFTER CONNECTIO DETAIL

SCALE: 1 : 10

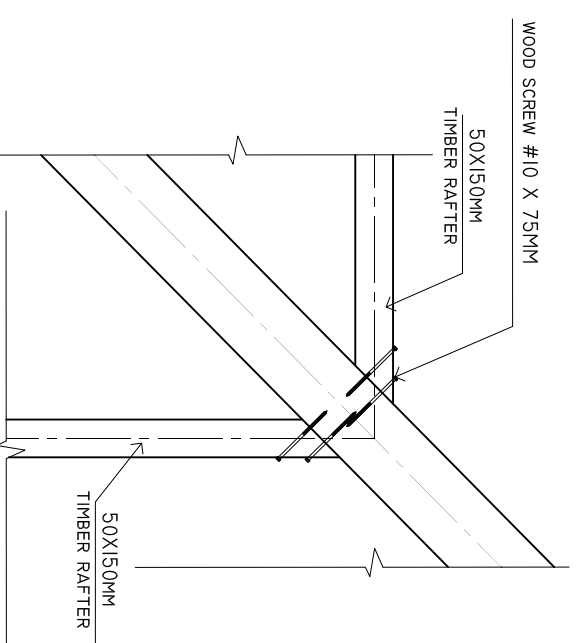

SHEET CONTENTS :

REVISION NOTES:

PROJECT:
CONSTRUCTION OF
AMBULANCE PORTICO

CLIENT:

MINISTRY OF HEALTH

LOCATION:

DIFERENT ISLANDS

CONTENTS: AS GIVEN

PROJECT MANAGER:

DESIGNER: ARIZ

CIV/STR. ENGINEER:

SURVEYED BY: -

DRAWN BY: ARIZ

CHECKED BY:

DATE : FEBRUARY 2021


SHEET NO. : /

PAPER SIZE: A3



PAVING AREA DETAILS

SCALE: 1 : 10

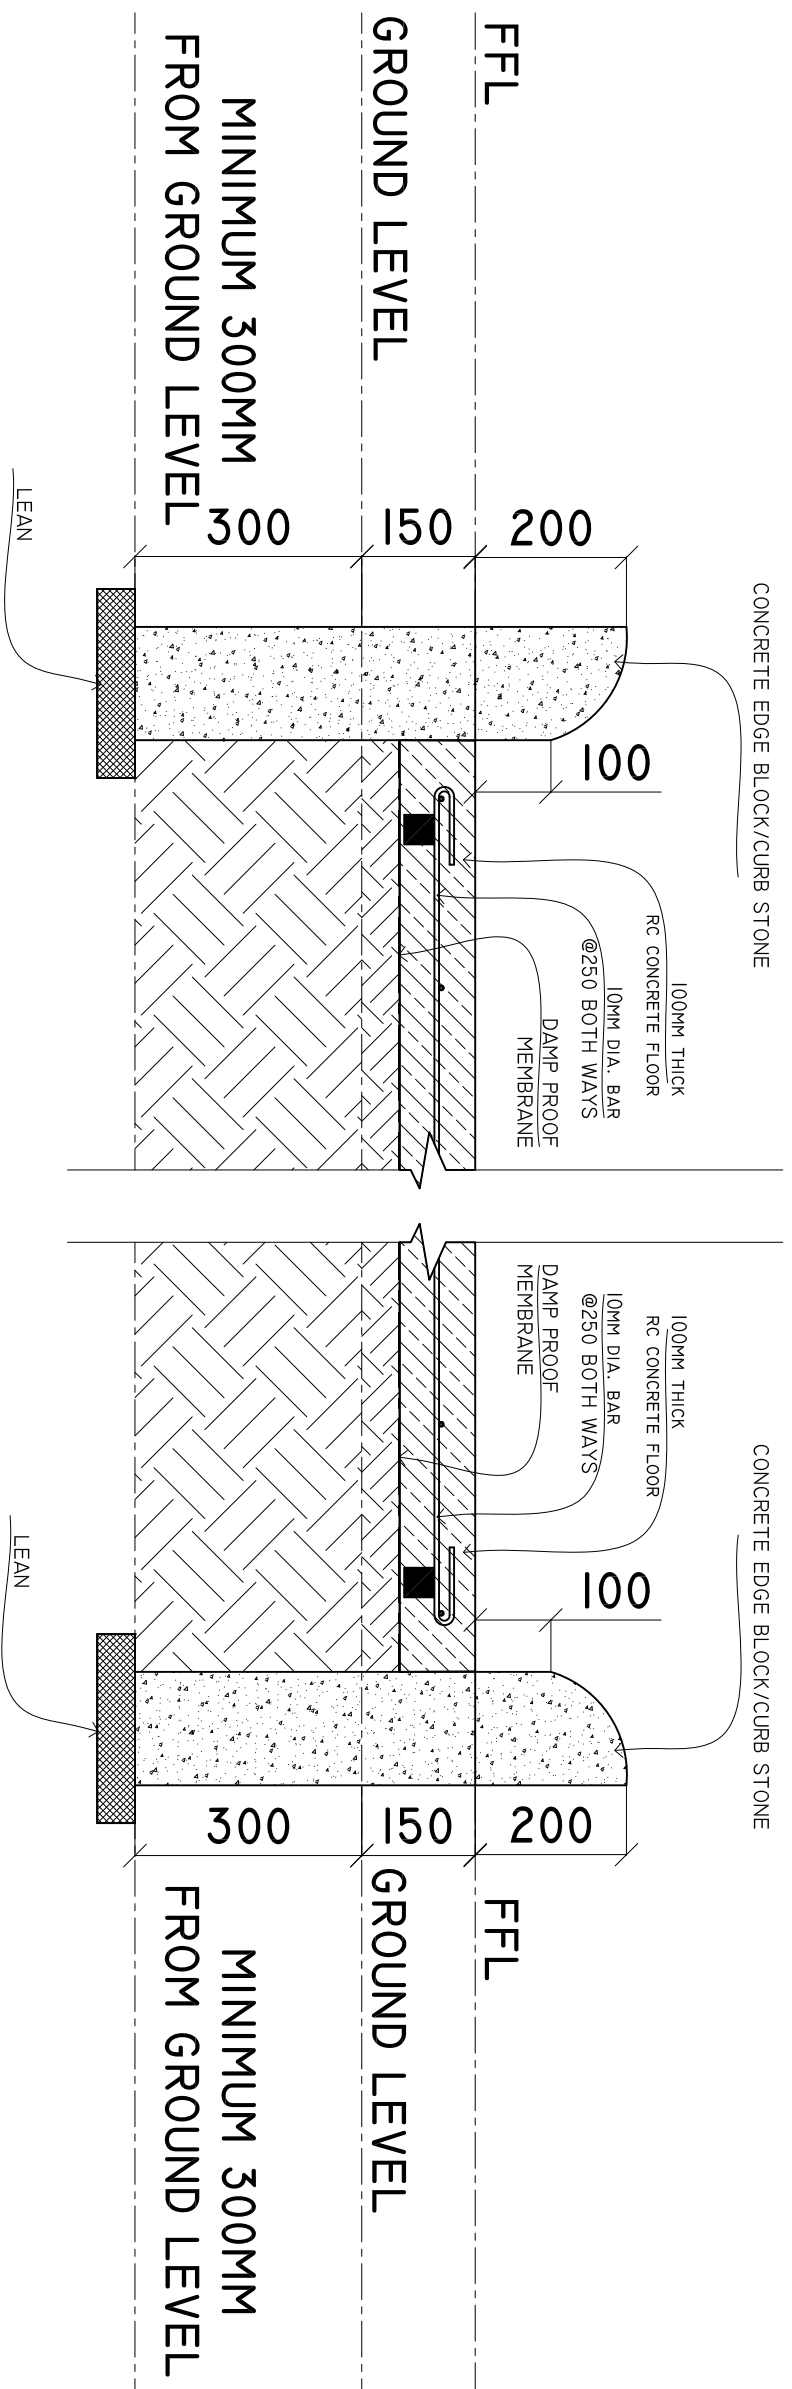

NOTE:

THE PAVING AREA SLOPE STARTS FROM THE ROADS TO THE FLOOR FINISH LEVEL OF THE PORTICO AREA.

SHEET CONTENTS :

REVISION NOTES:

PROJECT:
CONSTRUCTION OF
AMBULANCE PORTICO

CLIENT:
MINISTRY OF HEALTH

LOCATION:
DIFFERENT ISLANDS

CONTENTS: AS GIVEN

PROJECT MANAGER:

DESIGNER: ARIZ

CIV/STR. ENGINEER:

SURVEYED BY: -

DRAWN BY: ARIZ

CHECKED BY:

DATE : FEBRUARY 2021

SHEET NO. : /

PAPER SIZE: A3

