

PROPOSED SINGLE STOREY TOILET BLOCK


**ARCHITECTURAL & STRUCTURAL DRAWINGS
ELECTRICAL & PLUMBING**

MAY 2016

CLIENT : MINISTRY OF EDUCATION

DESIGN BY

ArchEng
s t u d i o
Ma Fiyajahaage, 1st floor, Male', Republic of Maldives
admin@archeng.biz

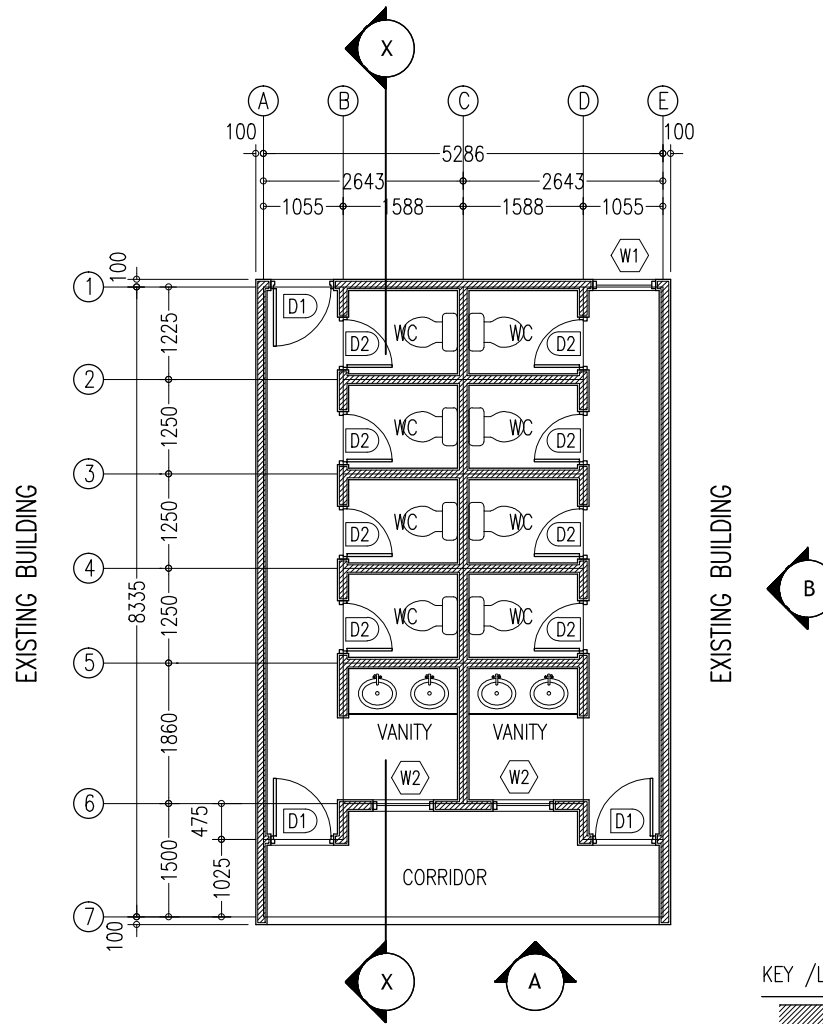


FLOOR LAYOUT PLAN
SCALE 1:100

CONTRACTORS MUST CHECK ALL DIMENSIONS ON SITE BEFORE STARTING ANY WORK OR SHOP DRAWINGS FIGURED DIMENSIONS TO TAKE PRECEDENCE OVER SCALE READINGS




REVISION	ARCHITECT: MOHAMED HAMEEN	PROJECT: TOILET BLOCK	A-01 DWG NO PROJECT NO.: 14-109
	ENGINEER: MOHAMED AHSAN	LOCATION: HJH,NDUH#ARAW	
	SERVICES ENG:	DRAWING TITLE: AS GIVEN	
	ESTIMATOR:	CLIENT: MINISTRY OF EDUCATION	
	DRAWN BY: IBRAHIM FARISH (SAYYA)	SCALE: AS GIVEN DIMENSION: MM DATE: MAY 2016	


CONCEPT AND DESIGN IN THE DRAWING ARE THE PROPERTIES OF ARCHENG STUDIOS PVT LTD UNAUTHORIZED USE OR REPRODUCTION OF PART OF THE DESIGN DRAWING OR CONCEPT TO USE IN OTHER PROJECTS OR FOR OTHER THAN SPECIFIED ON THE DRAWING IS PROHIBITED

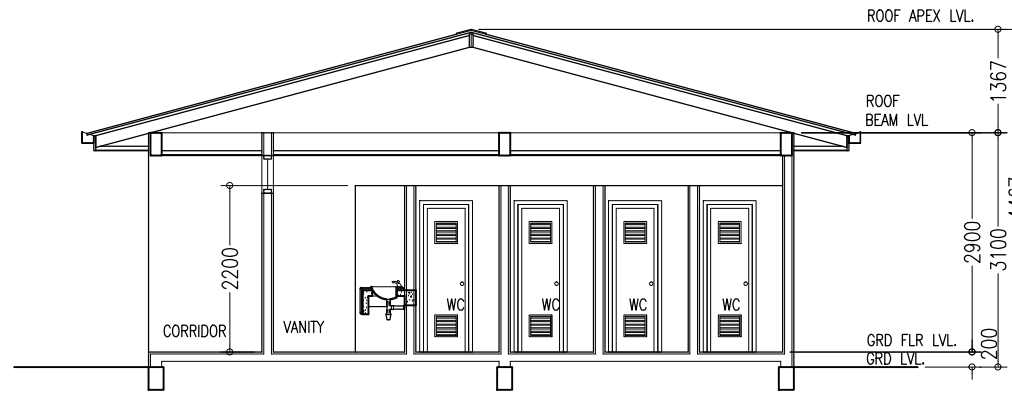

SECTION X-X
SCALE 1:100

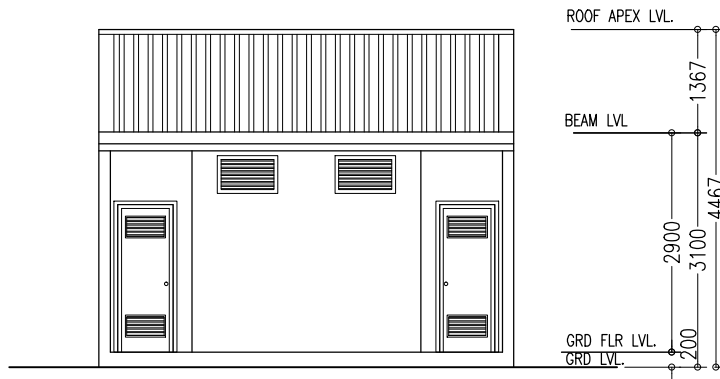

ELEVATION-A
SCALE 1:100

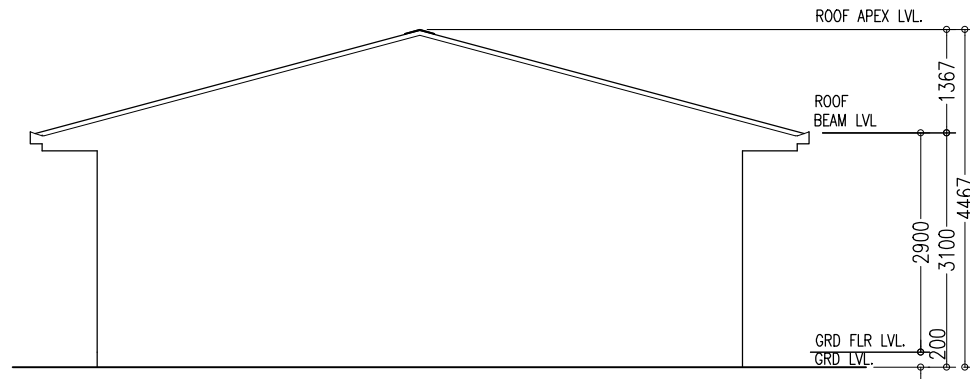


ELEVATION-B
SCALE 1:100


CONTRACTORS MUST CHECK ALL DIMENSIONS ON SITE BEFORE STARTING ANY WORK OR SHOP DRAWINGS FIGURED DIMENSIONS TO TAKE PRECEDENCE OVER SCALE READINGS



REVISION:	ARCHITECT: MOHAMED HAMEEN	PROJECT: TOILET BLOCK	A-02
	ENGINEER: MOHAMED AHSAN	LOCATION: HDMACUHIYARAM	
	SERVICES ENG:	DRAWING TITLE: AS GIVEN	
	ESTIMATOR:	CLIENT: MINISTRY OF EDUCATION	
	DRAWN BY: BRAHM FARISHI (SAYYA)	SCALE: AS GIVEN DIMENSION: MM DATE: MAY 2016	
CONCEPT AND DESIGN IN THE DRAWING ARE THE PROPERTIES OF ARCH LONG PVT.LTD. UNAUTHORIZED USE OR REPRODUCTION OF PART OF THE DESIGN DRAWING OR CONCEPT TO USE IN OTHER PROJECTS OR OTHER THAN SPECIFIED ON THE DRAWING IS PROHIBITED.			DWG NO: PROJECT NO.: 14-109

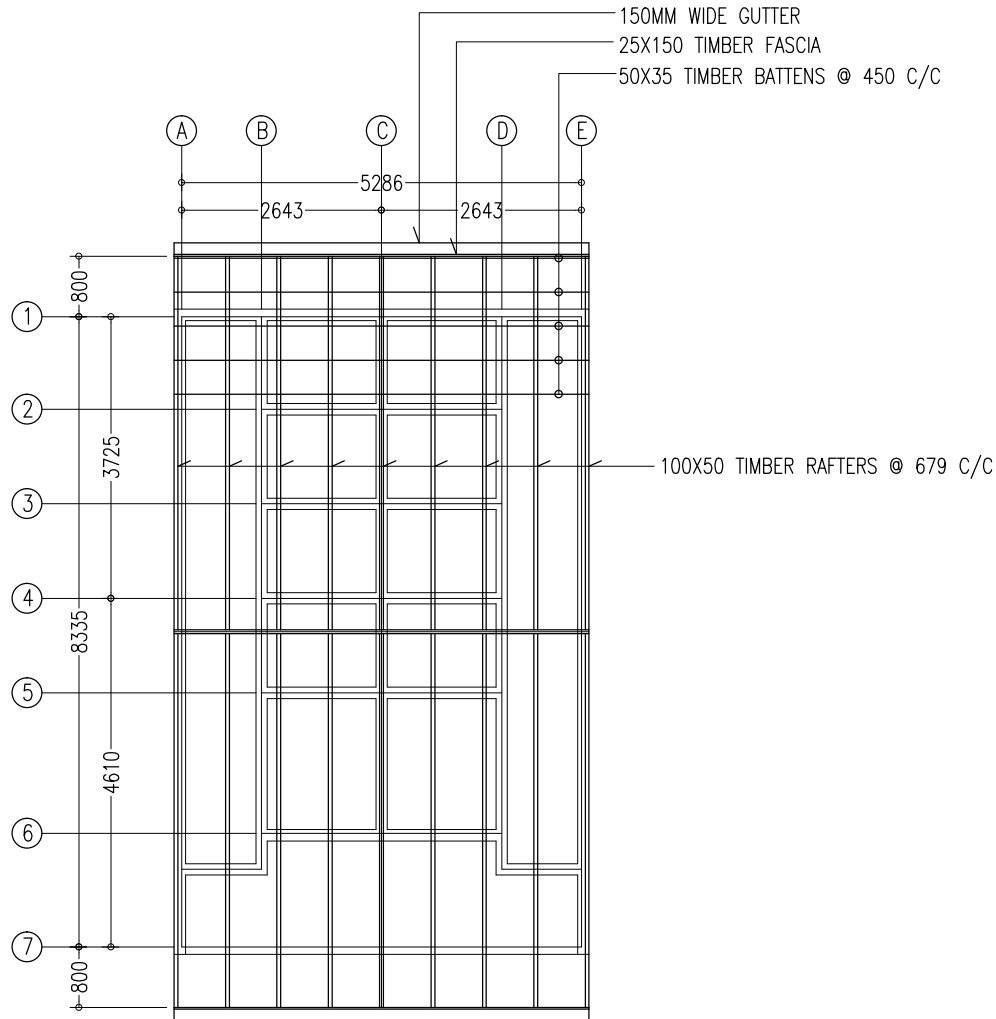

ROOF STRUCTURE PLAN
SCALE 1:100

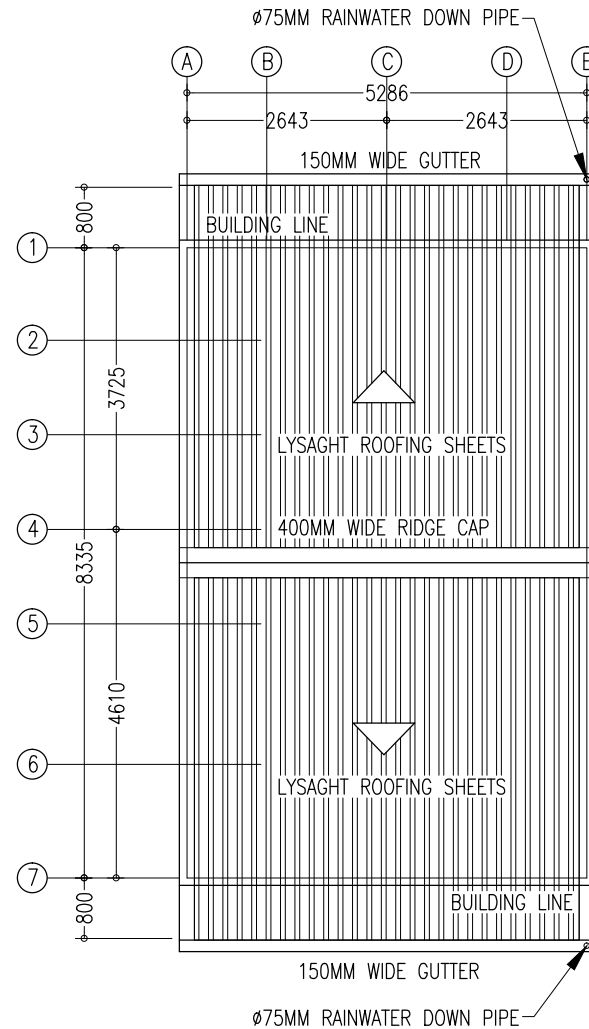

ROOF STRUCTURE PLAN
SCALE 1:100

CONTRACTORS MUST CHECK ALL DIMENSIONS ON SITE BEFORE STARTING ANY WORK OR SHOP DRAWINGS PROVIDED DIMENSIONS TO TAKE PRECEDENCE OVER SCALE READINGS



REVISION:	ARCHITECT: MOHAMED HAMEEN	PROJECT: TOILET BLOCK	A-03 DWG NO	
	ENGINEER: MOHAMED AHSAN	LOCATION: RDHAKOUH WARAMI		
	SERVICES ENG:	DRAWING TITLE: AS GIVEN		
	ESTIMATOR:	CLIENT: MINISTRY OF EDUCATION		
	DRAWN BY: IBRAHIM FARISH (SAYYA)	SCALE: AS GIVEN		
CONCEPT AND DESIGN IN THIS DRAWING ARE THE PROPERTIES OF ARCHENG STUDIOS PVT. LTD. UNAUTHORIZED USE OR REPRODUCTION OF PART OF THE DESIGN DRAWINGS OR CONCEPT TO USE IN OTHER PROJECTS OR SITES OTHER THAN SPECIFIED ON THIS DRAWING IS PROHIBITED.		DIMENSION: MM	DATE: MAY 2016	PROJECT NO.: 14-109

ELEVATIONS :				
	200	200		
DR / WD NO.	D1	D2	W1	W2
DESCRIPTION :	40MM THICK OPENABLE ALUMINIUM DOOR PANEL	40MM THICK OPENABLE SOLID TIMBER DOOR PANEL	ALUMINIUM FRAMED WINDOW PANEL	ALUMINIUM FRAMED FIXED LOUVERS
FRAME :	40 MICRON WHITE POWDER COATED ALUMINIUM FRAME	120MM TIMBER FRAME	40 MICRON WHITE POWDER COATED ALUMINIUM FRAME	40 MICRON WHITE POWDER COATED ALUMINIUM FRAME
HARDWARE :	DOOR CLOSER CYLINDRICAL LOCK BUTT HINGE STOPPER HOLDER	DOOR CLOSER CYLINDRICAL LOCK BUTT HINGE STOPPER HOLDER		
GLAZING :	C-4MM	C-4MM ALL FIXED PANELS TO BE SINGLE GLAZED	C-5MM THICK CLEAR GLASS	

GENERAL NOTES:

SHOP DRAWINGS FOR ALL DOORS AND WINDOWS SHALL BE PROVIDED SHOWING LOCATION AND TYPE OF IRONMONGERIES

ALL DIMENSIONS TO BE CHECKED ON SITE PRIOR TO FABRICATION

ALL TIMBER FOR WOODEN DOORS SHALL BE TREATED FOR THE USE IN INDOORS.

- G : GLASS
- FG : FIXED GLASS
- FAL : FIXED ALUMINIUM LOUVERS


DOOR / WINDOW SCHEDULE

SCALE 1:50


CONTRACTORS MUST CHECK ALL DIMENSIONS ON SITE BEFORE STARTING ANY WORK OR SHOP DRAWINGS REQUIRED DIMENSIONS TO TAKE PRECEDENCE OVER SCALE READINGS



REVISION:	ARCHITECT: MOHAMED HAMEEN	PROJECT: TOILET BLOCK	A-04
	ENGINEER: MOHAMED AH-SAN	LOCATION: H.D.HANOUH WARAM	
	SERVICES ENG:	DRAWING TITLE: AS GIVEN	
	ESTIMATOR:	CLIENT: MINISTRY OF EDUCATION	
	DRAWN BY: IBRAHIM FARISH (SAYYA)	SCALE: AS GIVEN DIMENSION: 1MM DATE: MAY 2018	
CONCEPT AND DESIGN IN THIS DRAWING ARE THE PROPERTIES OF ARCHENG STUDIO PVT.LTD. UNAUTHORIZED USE OR REPRODUCTION OF PART OF THE DESIGN DRAWINGS OR CONCEPT TO USE IN OTHER PROJECTS OR SITES OTHER THAN SPECIFIED ON THE DRAWING IS PROHIBITED			DWG NO PROJECT NO.: 14-109

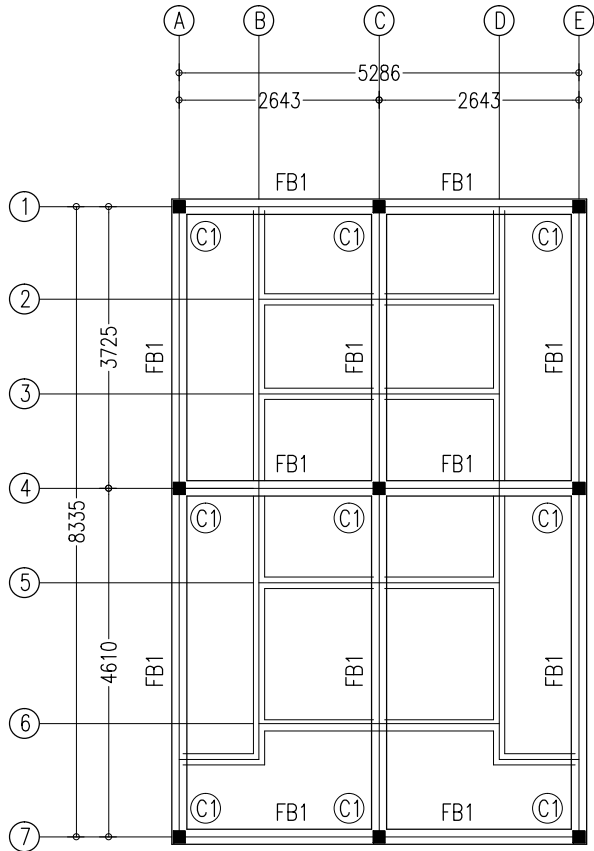

FOUNDATION PLAN
SCALE 1:100


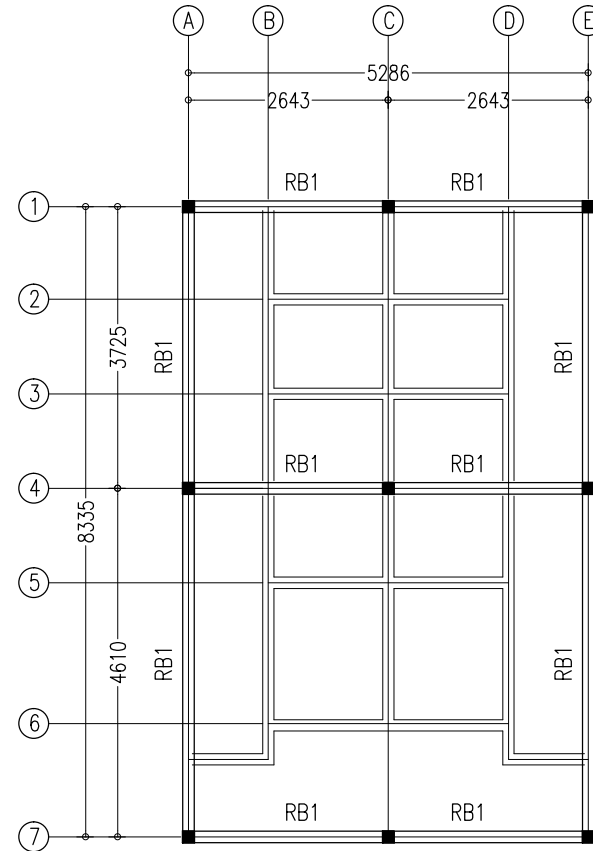


ROOF BEAM PLAN
SCALE 1:100

CONTRACTORS MUST CHECK ALL DIMENSIONS ON SITE BEFORE STARTING ANY WORK OR SHOP DRAWINGS. REQUED DIMENSIONS TO TAKE PRECEDENCE OVER SCALE READINGS



REVISION:	ARCHITECT: MOHAMED HAMEEN	PROJECT: TOILET BLOCK	S-01
	ENGINEER: MOHAMED AHSAN	LOCATION: H.DH.NDLM/IRAM	
	SERVICES ENG:	DRAWING TITLE: AS GIVEN	
	ESTIMATOR:	CLIENT: MINISTRY OF EDUCATION	
	DRAWN BY: IBRAHIM FARISH (SAYYA)	SCALE: AS GIVEN	
		DIMENSION: MM	DATE: MAY 2016
CONCEPT AND DESIGN. THE DRAWING ARE THE PROPERTIES OF ARCHLONG STUDIO PVT LTD. UNAUTHORIZED USE OR REPRODUCTION OF PART OF THE DESIGN DRAWINGS OR CONCEPT TO USE IN OTHER PROJECTS OR BY OTHER THAN SPECIFIED ON THE DRAWING IS PROHIBITED.			DWG NO: PROJECT NO.: 14-109

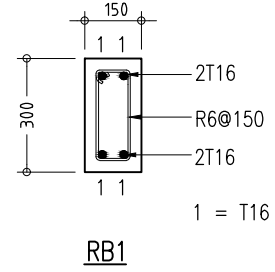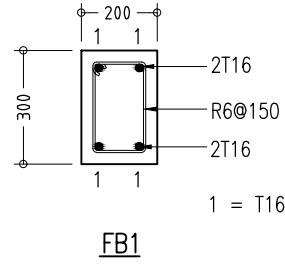


FOUNDATION BEAM DETAILS

SCALE 1:20

ROOF BEAM DETAIL

SCALE 1:20

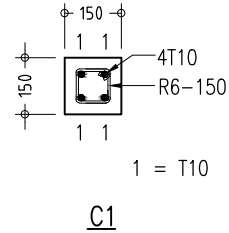


COLUMN DETAILS

SCALE 1:20

CONTRACTORS MUST
CHECK ALL
DIMENSIONS ON SITE
BEFORE STARTING
ANY WORK OR SHOP
DRAWINGS. REQUIRED
DIMENSIONS TO TAKE
PRECEDENCE OVER
SCALE READINGS


ArchEng
studios
No. 77, Al-Rajha, 1st Floor, Kuba, Republic of Maldives
info@archengstudios.com

REVISION:	ARCHITECT: MOHAMED HAMEEN	PROJECT: TOILET BLOCK	S-02
	ENGINEER: MOHAMED AHASAN	LOCATION: H.D.KUNLIHARAM	
	SERVICES ENG:	DRAWING TITLE: AS GIVEN	
	ESTIMATOR:	CLIENT: MINISTRY OF EDUCATION	
	DRAWN BY: IBRAHIM FARISH (SAYYA)	SCALE: AS GIVEN DIMENSION: MM DATE: MAY 2016	
CONCEPT AND DESIGN IN THIS DRAWING ARE THE PROPERTIES OF ARCHENG STUDIOS PVT.LTD. UNAUTHORIZED USE OR REPRODUCTION OF PART OF THE DESIGN DRAWINGS OR CONCEPT TO USE IN OTHER PROJECTS OR SITES OTHER THAN SPECIFIED ON THIS DRAWING IS PROHIBITED.			DWG NO PROJECT NO: 14-109

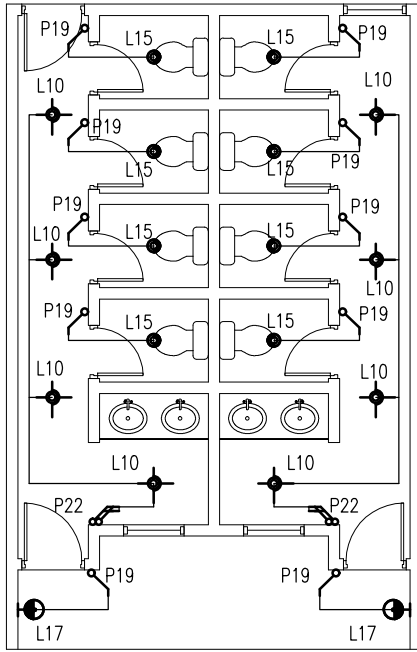


LIGHTING LAYOUT PLAN

SCALE 1:100

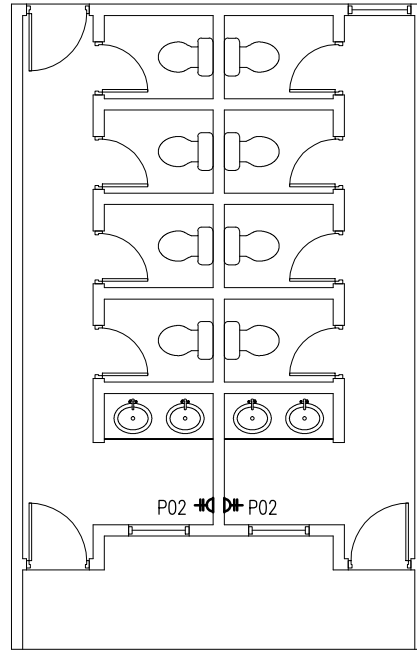

SOCKET LAYOUT PLAN

SCALE 1:100

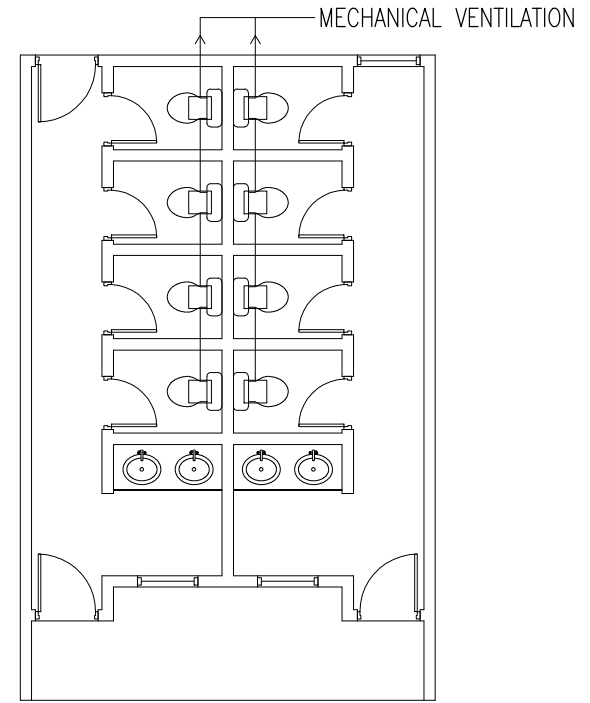

FAN LAYOUT PLAN

SCALE 1:100

LEGEND

SYMBOL	CODE	DESCRIPTION
	L10	1X26W COMPACT FLUORESCENT LAMPS IN RECESSED DECORATIVE LUMINAIRE
	L15	1X60W INCANDESCENT LAMPS IN RECESSED DECORATIVE LUMINAIRE
	L17	1X60W INCANDESCENT LAMPS IN SURFACE MOUNT WEATHER PROOF LUMINAIRE

LEGEND


SYMBOL	CODE	DESCRIPTION
	P19	1GANG 1 WAY SWITCH
	P22	4GANG 1 WAY SWITCH
	P02	2 GANG 13A SOCKET OUTLET AT 300mm ABOVE FINISHED FLOOR LEVEL

CONTRACTORS MUST CHECK ALL DIMENSIONS ON-SITE BEFORE STARTING ANY WORK OR SHOP DRAWINGS. REQUIRED DIMENSIONS TO TAKE PRECEDENCE OVER SCALE READINGS




REVISION:	ARCHITECT: MOHAMED HAMEEN	PROJECT: TOILET BLOCK	E-01
	ENGINEER: MOHAMED AHASAN	LOCATION: HDK NOLHARAM	
	SERVICES ENG:	DRAWING TITLE: AS GIVEN	
	ESTIMATOR:	CLIENT: MINISTRY OF EDUCATION	
	DRAWN BY: BRAHMI FARISH SAYYA	SCALE: AS GIVEN DIMENSION: MM DATE: MAY 2018	
CONCEPT AND DESIGN IN THIS DRAWING ARE THE PROPERTIES OF ARCH-ENG STUDIO PVT. LTD. UNAUTHORIZED USE OR REPRODUCTION OF PART OF THE DESIGN DRAWINGS OR CONCEPT TO USE IN OTHER PROJECTS OR FOR OTHER THAN SPECIFIED ON THIS DRAWING IS PROHIBITED.			DWG NO: PROJECT NO.: 14-109

Ø1.8M SEPTIC TANK

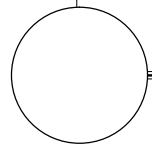


NOTE: TO BE DETERMINED ON SITE

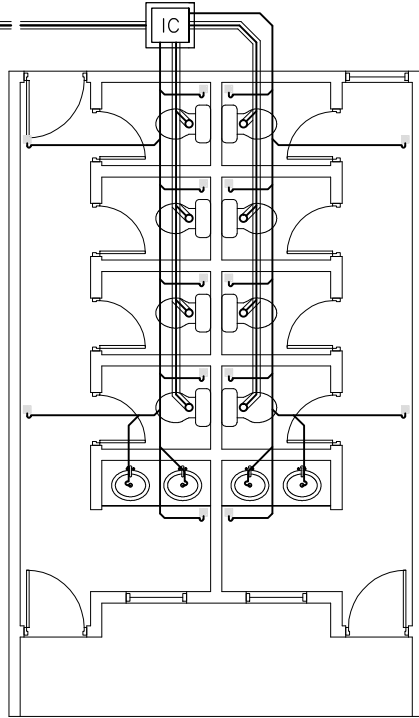


SEWAGE AND WASTE DISPOSAL PLAN

SCALE 1:100

 Ø1.2M GRD WELL



FROM GROUND WELL

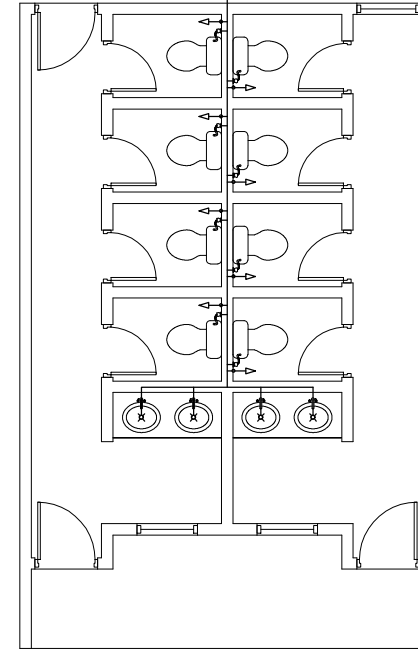

FRESH WATER SUPPLY PLAN

SCALE 1:100

LEGEND

SYMBOL	DESCRIPTION
	TAP
	MUSLIM SHOWER
	MWSC WATER SUPPLY (Ø12-Ø35)
	FLOOR DRAIN
	UPVC HIGH PRESSURE WASTE WATER PIPE (Ø75-Ø100)
	SEWAGE DISPOSAL (Ø100)
	INSPECTION CHAMBER

CONTRACTORS MUST CHECK ALL DIMENSIONS ON SITE BEFORE STARTING ANY WORK OR SHOP DRAWINGS FIGURED DIMENSIONS TO TAKE PRECEDENCE OVER SCALE READINGS



REVISION:	ARCHITECT: MOHAMED HAMEEN	PROJECT: TOILET BLOCK	P-01
	ENGINEER: MOHAMED AHASAN	LOCATION: H.D.KUNOLHARAM	
	SERVICES ENG:	DRAWING TITLE: AS GIVEN	
	ESTIMATOR:	CLIENT: MINISTRY OF EDUCATION	
	DRAWN BY: IBRAHIM FARISH (SAYYA)	SCALE: AS GIVEN DIMENSION: MM DATE: MAY 2018	
CONCEPT AND DESIGN IN THIS DRAWING ARE THE PROPERTIES OF ARCH-ENG STUDIO PVT. LTD. UNAUTHORIZED USE OR REPRODUCTION OF PART OF THE DESIGN DRAWINGS OR CONCEPT TO USE IN OTHER PROJECTS OR FOR OTHER THAN SPECIFIED ON THIS DRAWING IS PROHIBITED			DWG NO: PROJECT NO: 14-189