

**Proposed Two Storey Warehouse Complex
at Thilafushi Plot No.: S5-36
WAREHOUSE #3**

K. Thilafushi



DesignExpress

Architects + Engineers | ☎ +960 7775119
Registered in Maldives | № SP-2662/2016
www.designexpress.mv

GENERAL NOTES:
1. Do not scale drawings. Dimensions govern.
2. All dimensions are in millimeters and all levels are in meters unless noted otherwise.
3. All dimensions shall be verified on site before proceeding with work.
4. Any areas indicated on this sheet are approximate and indicative only.
5. Design Express shall be notified in writing of any discrepancies.

REV	DESCRIPTION	DATE
00	INCEPTION	21/04/2021

KEY PLAN



Design Express
H. KAFURUTHOLHIGE, JANAVAREE MAGU
MALÉ 20042, REPUBLIC OF MALDIVES
info@designexpress.mv
+960 777 5119
© Design Express 2021

CLIENT
AASANDHA COMPANY LTD.
PROJECT
PROPOSED TWO STOREY
WAREHOUSE 3 AT PLOT #: S5-36
K. THILAFUSHI
TITLE
DRAWING LIST

DESIGN STAGE
 CONCEPT DESIGN
 DESIGN DEVELOPMENT
 CONSTRUCTION DOCUMENTS
 AS-BUILT DRAWINGS

DRAWN BY: HANEEF | CHECKED BY: HANEEF
DISCIPLINE: GENERAL | SHEET SIZE: A3 | SCALE: NA
FIRST EMISSION: 21/04/2021 | DRAWING NUMBER: G-1.01 | REVISION: 00
UPDATE: 14/09/2021

GENERAL				
#	DRAWING TITLE	DWG #	REV.	REMARKS
01	Drawing list	G-1.01	00	
02	Location plan	G-2.01	00	

ARCHITECTURAL SERIES				
#	DRAWING TITLE	DWG #	REV.	REMARKS
03	Site plan	A-2.01	00	
04	Ground floor plan	A-2.02	00	
05	First floor plan	A-2.03	00	
06	Roof plan	A-2.04	00	
07	Elevation E1	A-3.01	00	
08	Elevation E2	A-3.02	00	
09	Section(s)	A-4.01	00	
10	Architectural details 1	A-5.01	00	
11	Architectural details 2	A-5.02	00	
12	Door window schedule 1	A-6.01	00	
13	Door window schedule 2	A-6.02	00	
14	Door window schedule 3	A-6.03	00	
15	Ventilation schedule	A-6.04	00	

G = General
A = Architectural
S = Structural
E = Electrical
P = Plumbing
F = Fire protection

1 = General
2 = Plans
3 = Elevations
4 = Sections
5 = Details
6 = Schedules


STRUCTURAL SERIES				
#	DRAWING TITLE	DWG #	REV.	REMARKS
16	General notes	S-1.01	00	
17	Foundation plan	S-2.01	00	
18	Ground floor slab plan	S-2.02	00	
19	First floor truss plan	S-2.02	00	
20	Ground floor bracing plan	S-2.02	00	
21	First floor joist plan	S-2.02	00	
22	Roof truss plan	S-2.03	00	
23	First floor bracing plan	S-2.03	00	
24	Roof framing plan	S-2.04	00	
25	Structural details 1	S-5.01	00	
26	Structural details 2	S-5.02	00	
27	Structural details 3	S-5.03	00	
28	Structural details 4	S-5.04	00	
29	Structural details 5	S-5.05	00	
30	Typical details	S-5.06	00	
31	Standard RC detailing rules	S-5.07	00	
32	Foundation protection method	S-5.08	00	

MEP SERIES				
#	DRAWING TITLE	DWG #	REV.	REMARKS
33	Ground floor electrical layout	E-2.01	00	
34	First floor electrical layout	E-2.02	00	
35	Ground floor plumbing layout	P-2.01	00	
36	Soak pit details	P-5.01	00	

- GENERAL NOTES:**
- 1. Do not scale drawings. Dimensions govern
 - 2. All dimensions are in millimeters and all levels are in meters unless noted otherwise
 - 3. All dimensions shall be verified on site before proceeding with work
 - 4. Any areas indicated on this sheet are approximate and indicative only
 - 5. Design Express shall be notified in writing of any discrepancies

REV	DESCRIPTION	DATE
00	INCEPTION	21/04/2021

KEY PLAN

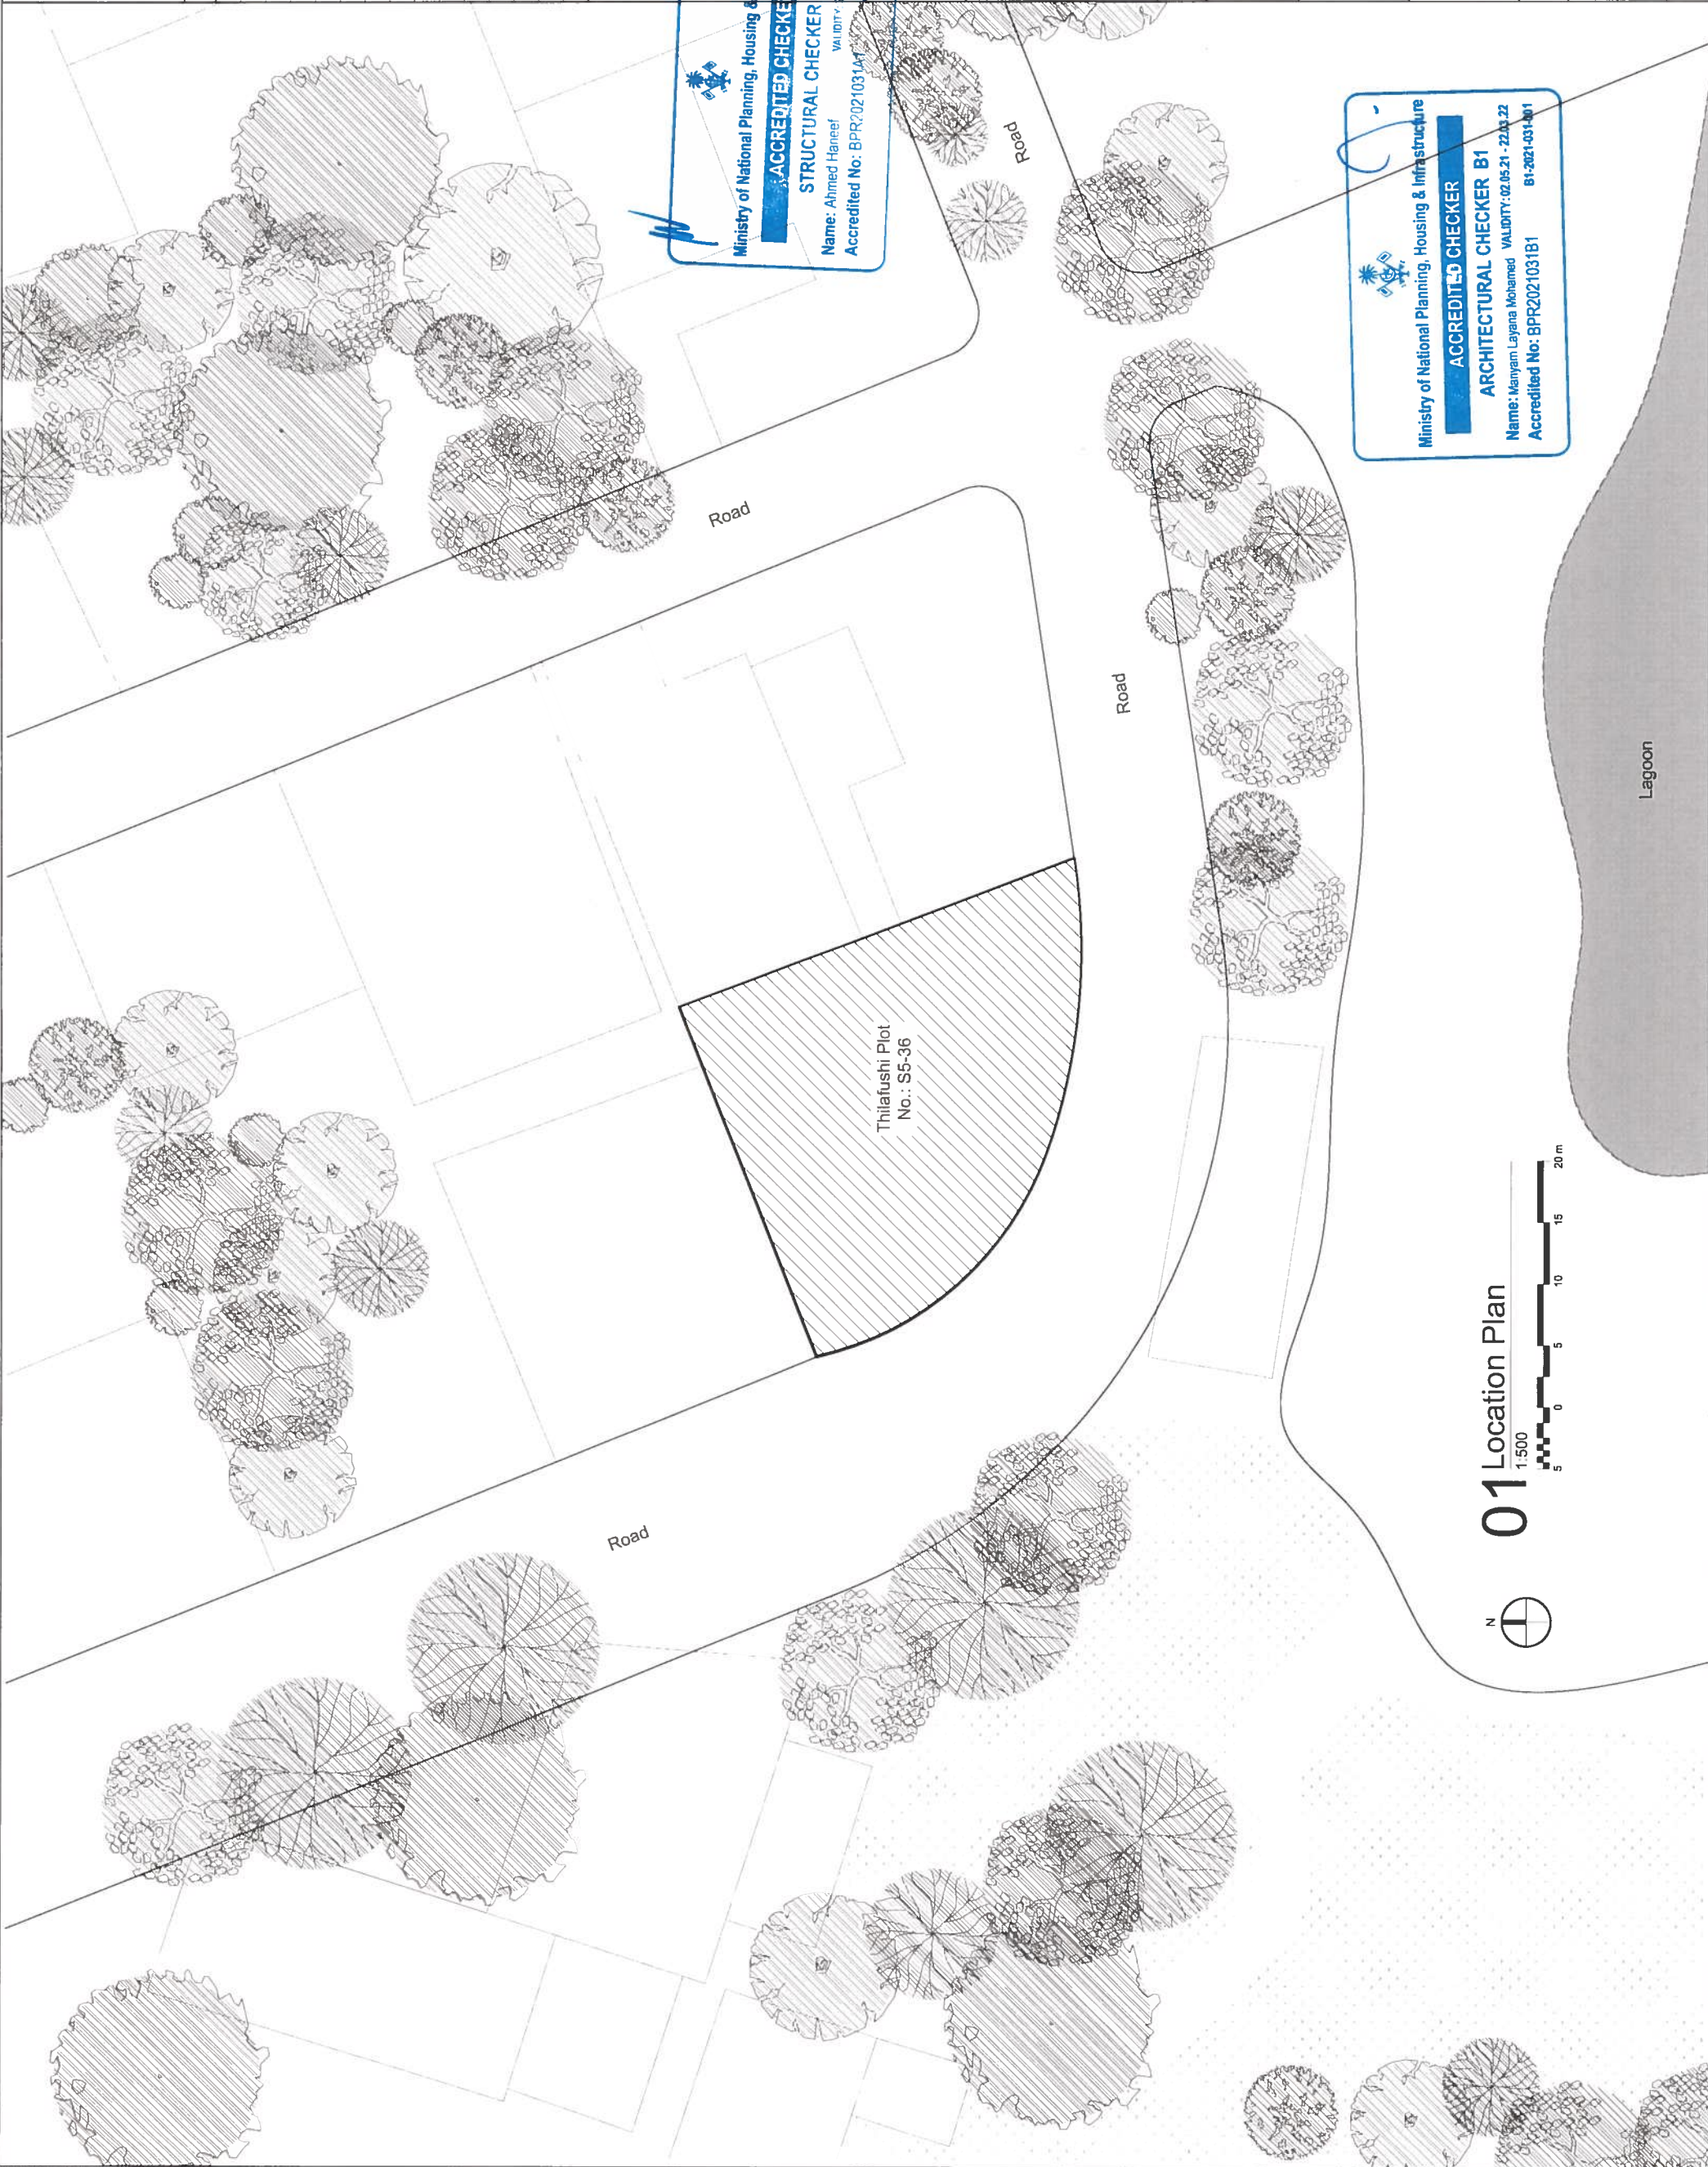

Design Express
 H. KAFURTHOLHIGE, JANAVAREE MAGU
 MALE 20042, REPUBLIC OF MALDIVES
 ✉ info@designexpress.mv
 ☎ +960 777 5119
 © Design Express 2021

CLIENT
AASANDHA COMPANY LTD.

PROJECT
**PROPOSED TWO STOREY
 WAREHOUSE 3 AT PLOT #: S5-36**

K. THILAFUSHI

TITLE
LOCATION PLAN

- DESIGN STAGE
- CONCEPT DESIGN
 - DESIGN DEVELOPMENT
 - CONSTRUCTION DOCUMENTS
 - AS-BUILT DRAWINGS

DRAWN BY
DE HANEEF

CHECKED BY
HANEEF

DISCIPLINE
GENERAL

SHEET SIZE
A3

SCALE
1:500

FIRST EMISSION
21/04/2021

DATE
21/04/2021

REVISION
G-2.01

UPDATE
14/09/2021

REVISION
00

01 Location Plan

1:500



Lagoon

Road

Road

Road

Thilafushi Plot
 No.: S5-36

Ministry of National Planning, Housing & Infrastructure

ACCREDITED CHECKER

STRUCTURAL CHECKER A1

Name: Ahmed Haneef VALIDITY: 23.03.21 - 22.03.22
 Accredited No: BPR2021031A1

Ministry of National Planning, Housing & Infrastructure

ACCREDITED CHECKER


ARCHITECTURAL CHECKER B1

Name: Mamgam Layana Mohamed VALIDITY: 02.05.21 - 22.03.22
 Accredited No: BPR2021031B1


- GENERAL NOTES:**
1. Do not scale drawings. Dimensions govern
 2. All dimensions are in millimeters and all levels are in meters unless noted otherwise
 3. All dimensions shall be verified on site before proceeding with work
 4. Any areas indicated on this sheet are approximate and indicative only
 5. Design Express shall be notified in writing of any discrepancies

REV	DESCRIPTION	DATE
00	INCEPTION	21/04/2021

CLIENT	AASANDHA COMPANY LTD.
PROJECT	PROPOSED TWO STOREY WAREHOUSE 3 AT PLOT #: S5-36
TITLE	SITE PLAN
DESIGN STAGE	<input type="radio"/> CONCEPT DESIGN <input type="radio"/> DESIGN DEVELOPMENT <input checked="" type="radio"/> CONSTRUCTION DOCUMENTS <input type="radio"/> AS-BUILT DRAWINGS
DRAWN BY	DESHNA
CHECKED BY	LAYANA
DISCIPLINE	ARCHITECTURAL
SHEET SIZE	A3
SCALE	1:200
FIRST EMISSION	21/04/2021
DRAWING NUMBER	A-2.01
REVISION	00
UPDATE	14/09/2021

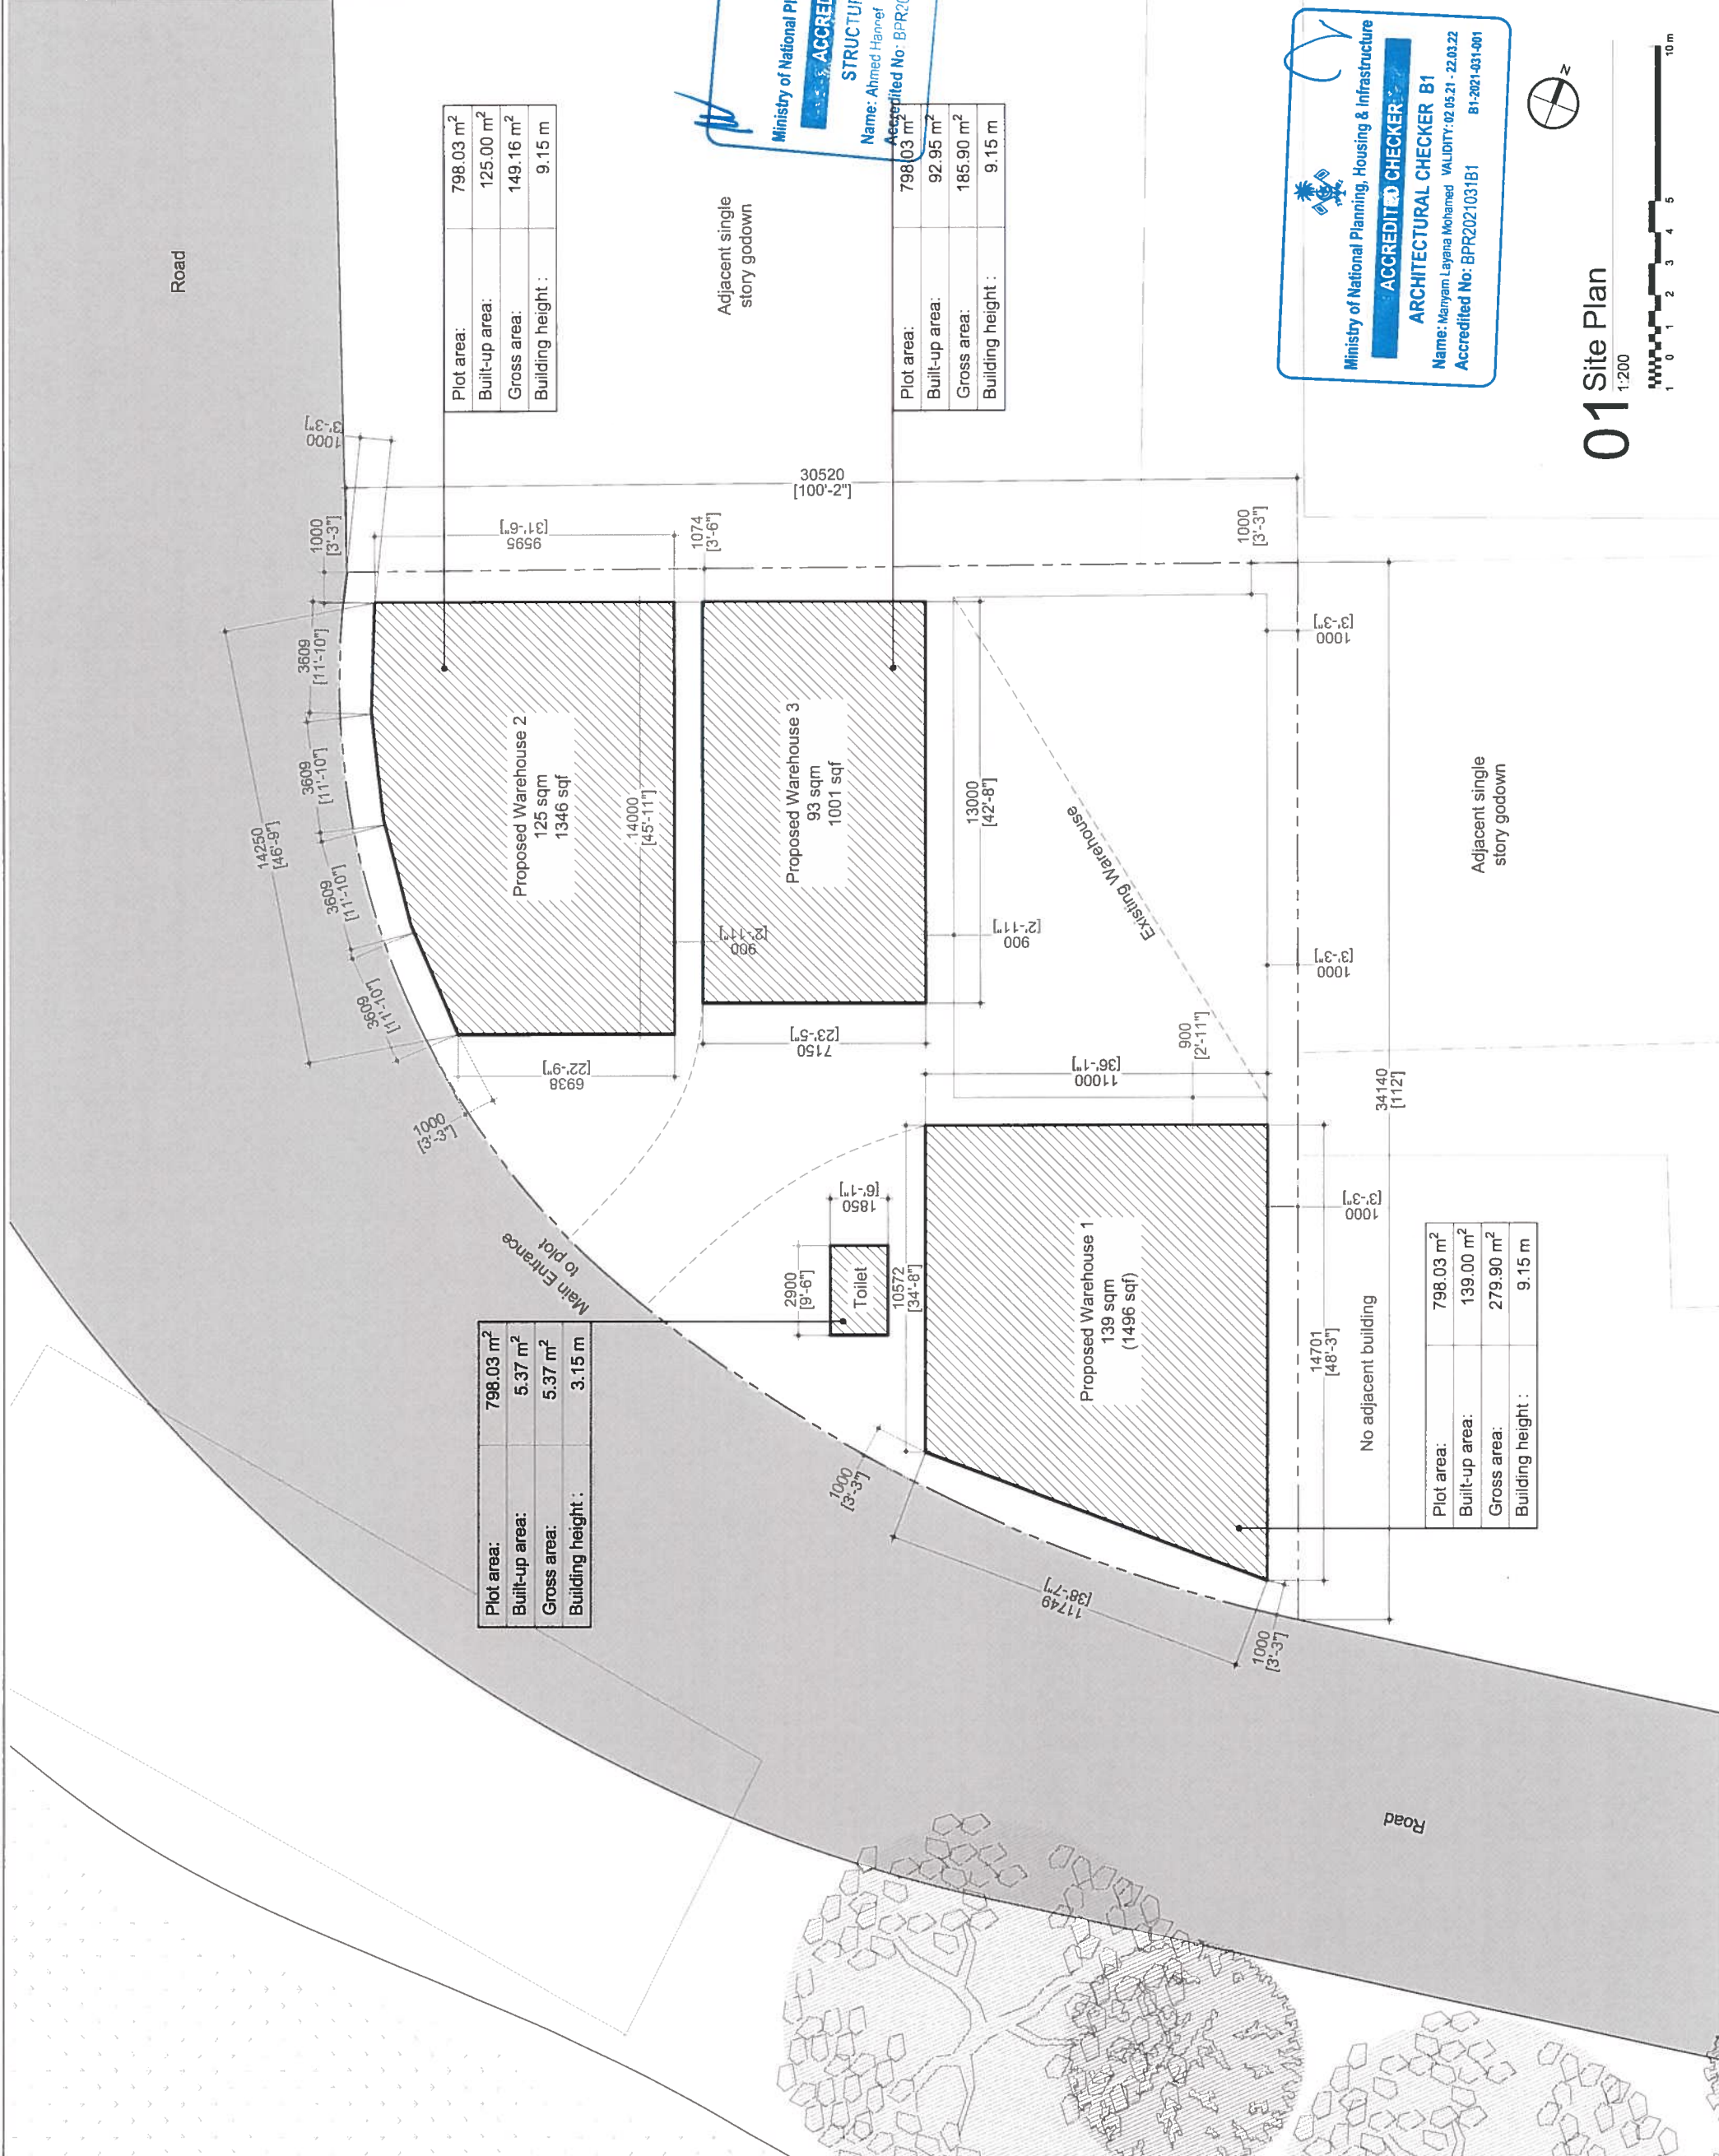

01 Site Plan

 

DesignExpress
 H. KAFURUTHOLHIGE, JANAVAREE MAGU
 MALÉ 20042, REPUBLIC OF MALDIVES
 info@designexpress.mv +960 777 5119 © Design Express 2021

GENERAL NOTES:

1. Do not scale drawings. Dimensions govern
2. All dimensions are in millimeters and all levels are in meters unless noted otherwise.
3. All dimensions shall be verified on site before proceeding with work
4. Any areas indicated on this sheet are approximate and indicative only
5. Design Express shall be notified in writing of any discrepancies

REV	DESCRIPTION	DATE
00	INCEPTION	21/04/2021

KEY PLAN


DesignExpress
 H. KAFURUTHOLHIGE, JANAVAREE MAGU
 MALÉ 20042, REPUBLIC OF MALDIVES
 E: info@designexpress.mv
 B: +960 777 5119
 © Design Express 2021

CLIENT
 AASANDHA COMPANY LTD.
 PROJECT
 PROPOSED TWO STOREY WAREHOUSE 3 AT PLOT #. S5-36
 K. THILAFUSHI
 TITLE
 GROUND FLOOR PLAN

DESIGN STAGE	DESIGNED BY	CHECKED BY	DATE
<input type="radio"/> CONCEPT DESIGN <input type="radio"/> DESIGN DEVELOPMENT <input checked="" type="radio"/> CONSTRUCTION DOCUMENTS <input type="radio"/> AS-BUILT DRAWINGS	DE	ISHA LAYANA	21/04/2021
DISCIPLINE	ARCHITECTURAL	SHEET SIZE	A3
FIRST EMISSION	21/04/2021	DRAWING NUMBER	1-100
UPDATE	14/09/2021	REVISION	A-2.02 00


Ministry of National Planning, Housing & Infrastructure
ACCREDITED CHECKER
STRUCTURAL CHECKER A1
 Name: Ahmed Haneef VALIDITY: 23.03.21 - 22.03.22
 Accredited No: BPR2021031A1 A1-2021-031-001

Ministry of National Planning, Housing & Infrastructure
ACCREDITED CHECKER
ARCHITECTURAL CHECKER B1
 Name: Maryam Layana Mohamed VALIDITY: 02.05.21 - 22.03.22
 Accredited No: BPR2021031B1 B1-2021-031-001

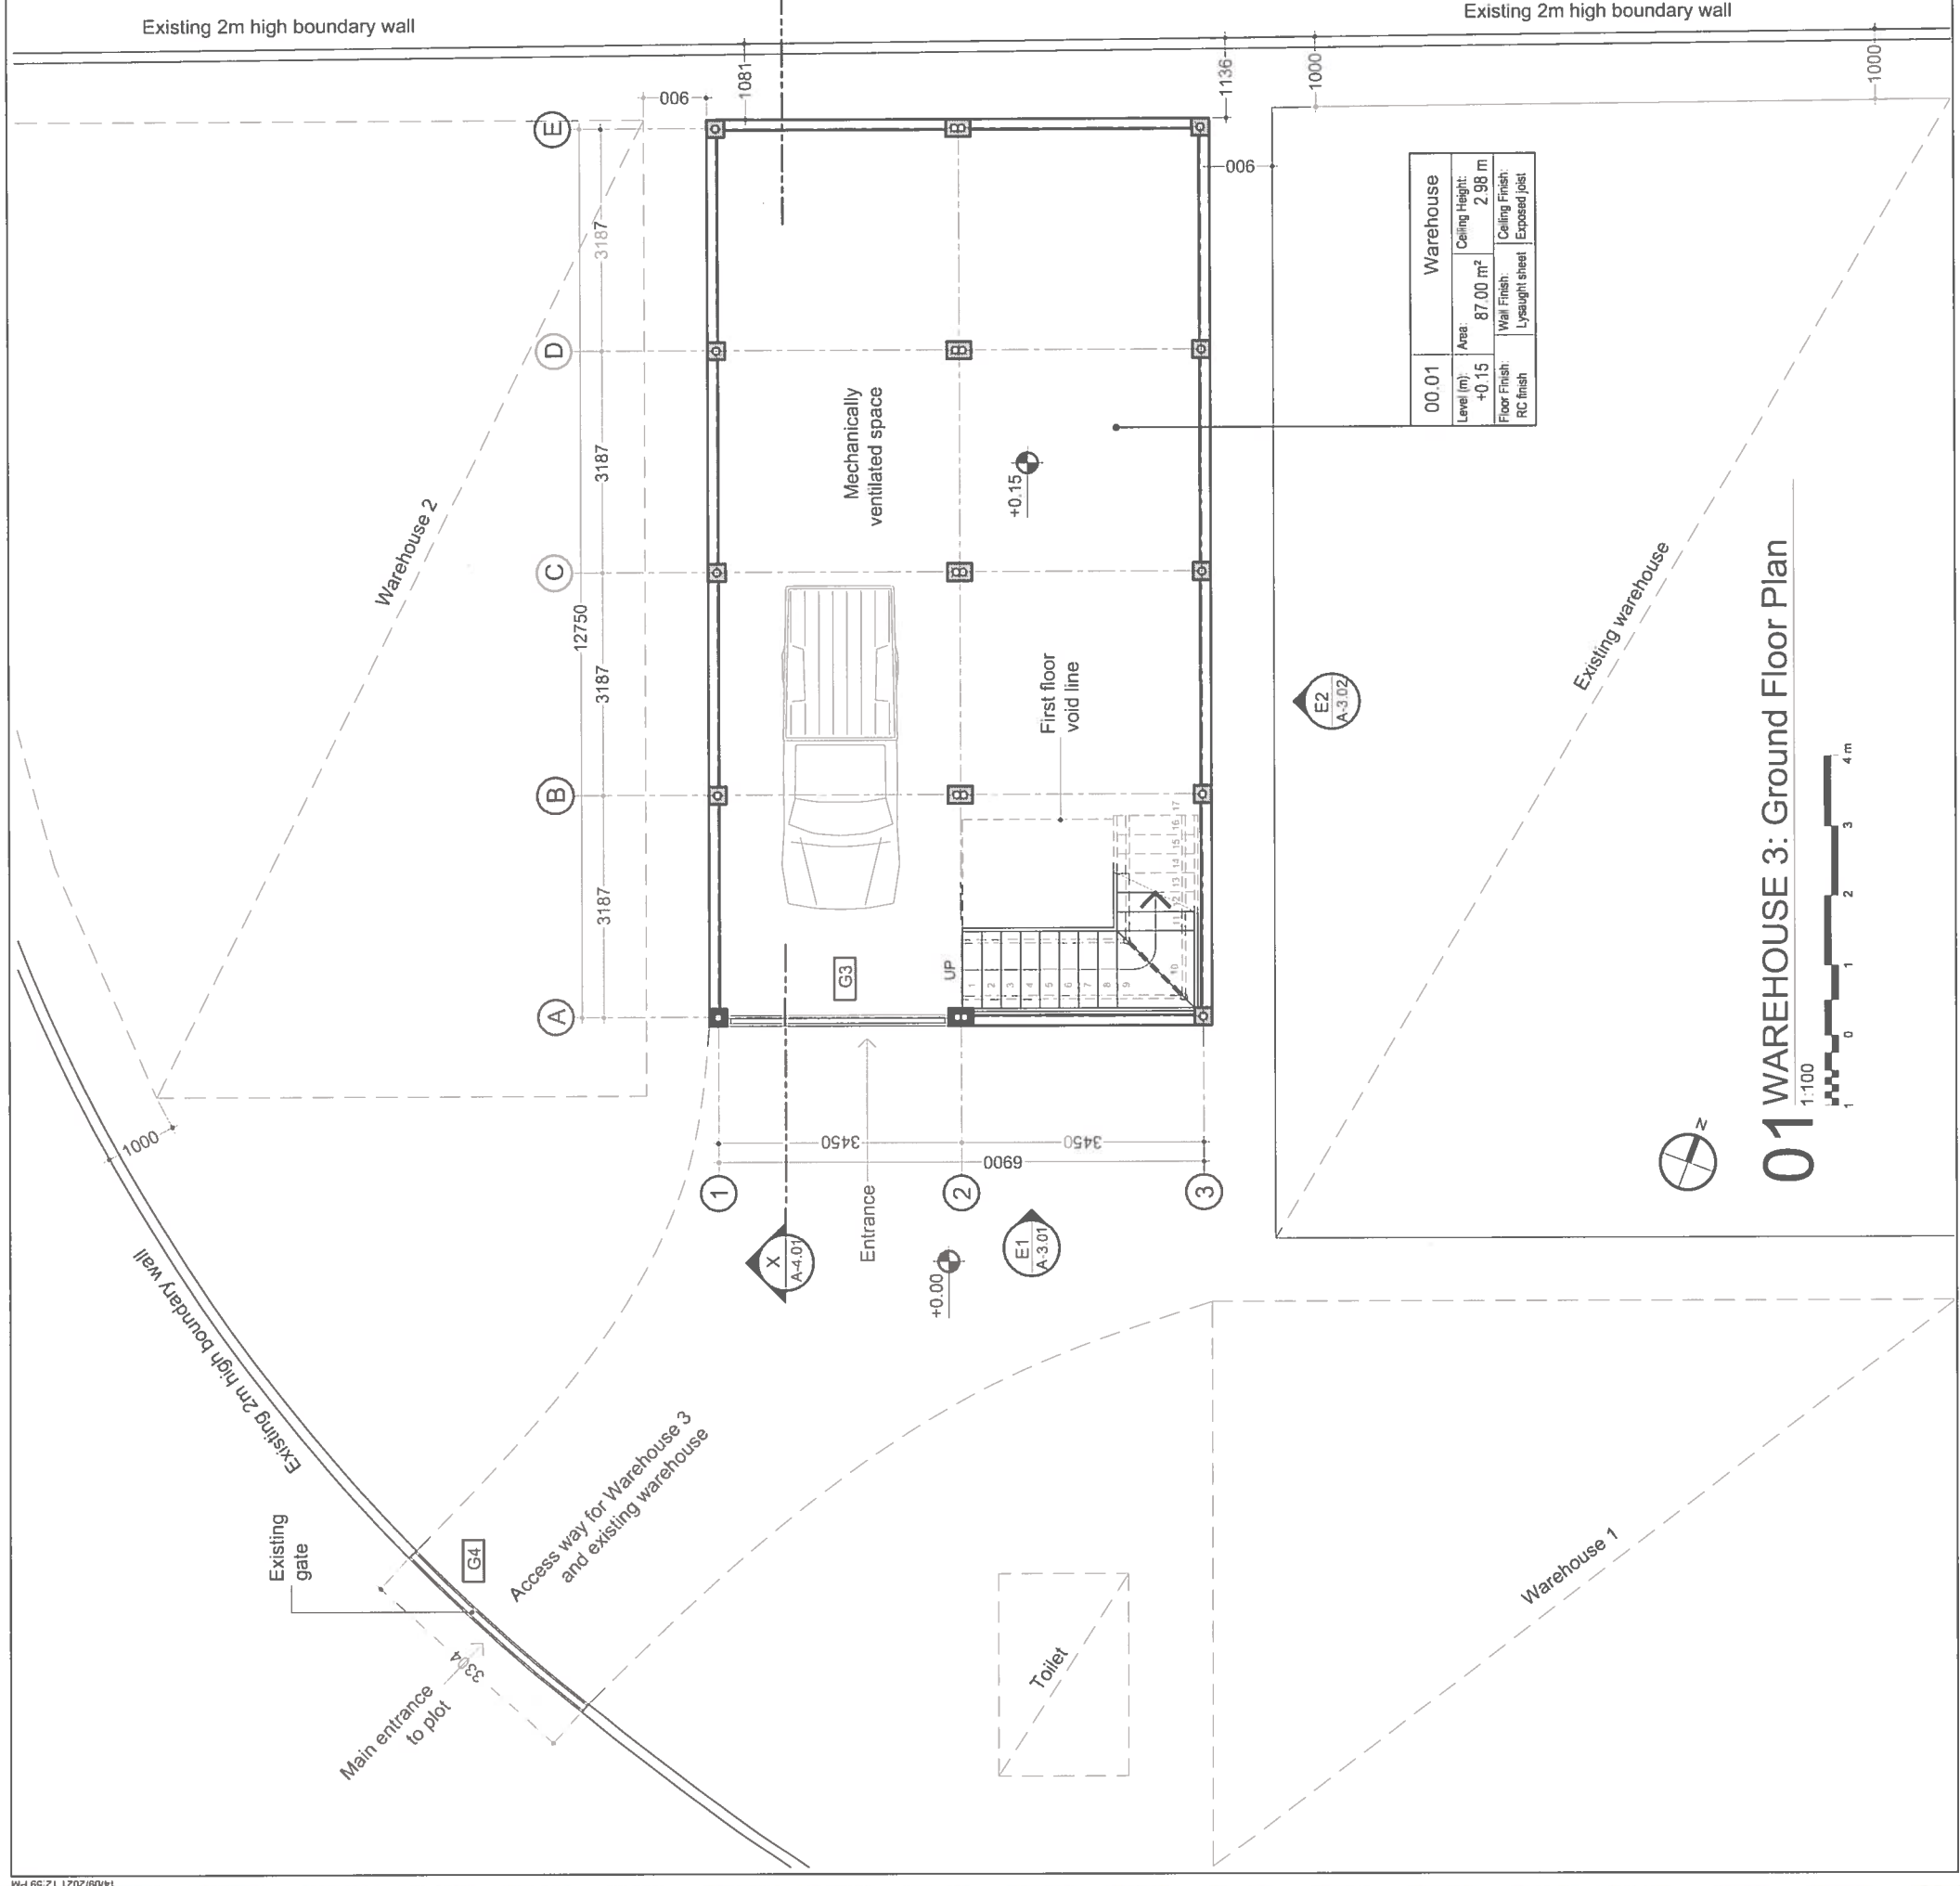

Warehouse	
00.01	
Level (m)	+0.15
Area	87.00 m²
Floor Finish	RC finish
Wall Finish	Lysaught sheet
Ceiling Height	2.98 m
Ceiling Finish	Exposed joist

 01 WAREHOUSE 3: Ground Floor Plan
 1:100



- GENERAL NOTES**
1. Do not scale drawings. Dimensions govern
 2. All dimensions are in millimeters and all levels are in meters unless noted otherwise
 3. All dimensions shall be verified on site before proceeding with work
 4. Any areas indicated on this sheet are approximate and indicative only
 5. Design Express shall be notified in writing of any discrepancies

REV	DESCRIPTION	DATE
00	INCEPTION	21/04/2021

KEY PLAN



Design Express
 H. KAFURUTHOLHIGE, JANAVAREE MAGU
 MALE 20042, REPUBLIC OF MALDIVES
 info@designexpress.mv
 +960 777 5119 © Design Express 2021

CLIENT
AASANDHA COMPANY LTD.

PROJECT
PROPOSED TWO STOREY WAREHOUSE 3 AT PLOT #: S5-36
 K. THILAFUSHI



TITLE
FIRST FLOOR PLAN

DESIGN STAGE
 CONCEPT DESIGN
 DESIGN DEVELOPMENT
 CONSTRUCTION DOCUMENTS
 AS-BUILT DRAWINGS

DRAWN BY: DE
 DESIGNED BY: ISHA
 CHECKED BY: LAYANA

DISCIPLINE: ARCHITECTURAL
 SHEET SIZE: A3
 SCALE: 1:100

FIRST EMISSION: 21/04/2021
 DRAWING NUMBER: A-2.03
 REVISION: 00
 UPDATE: 14/09/2021

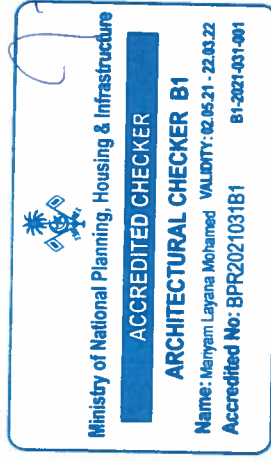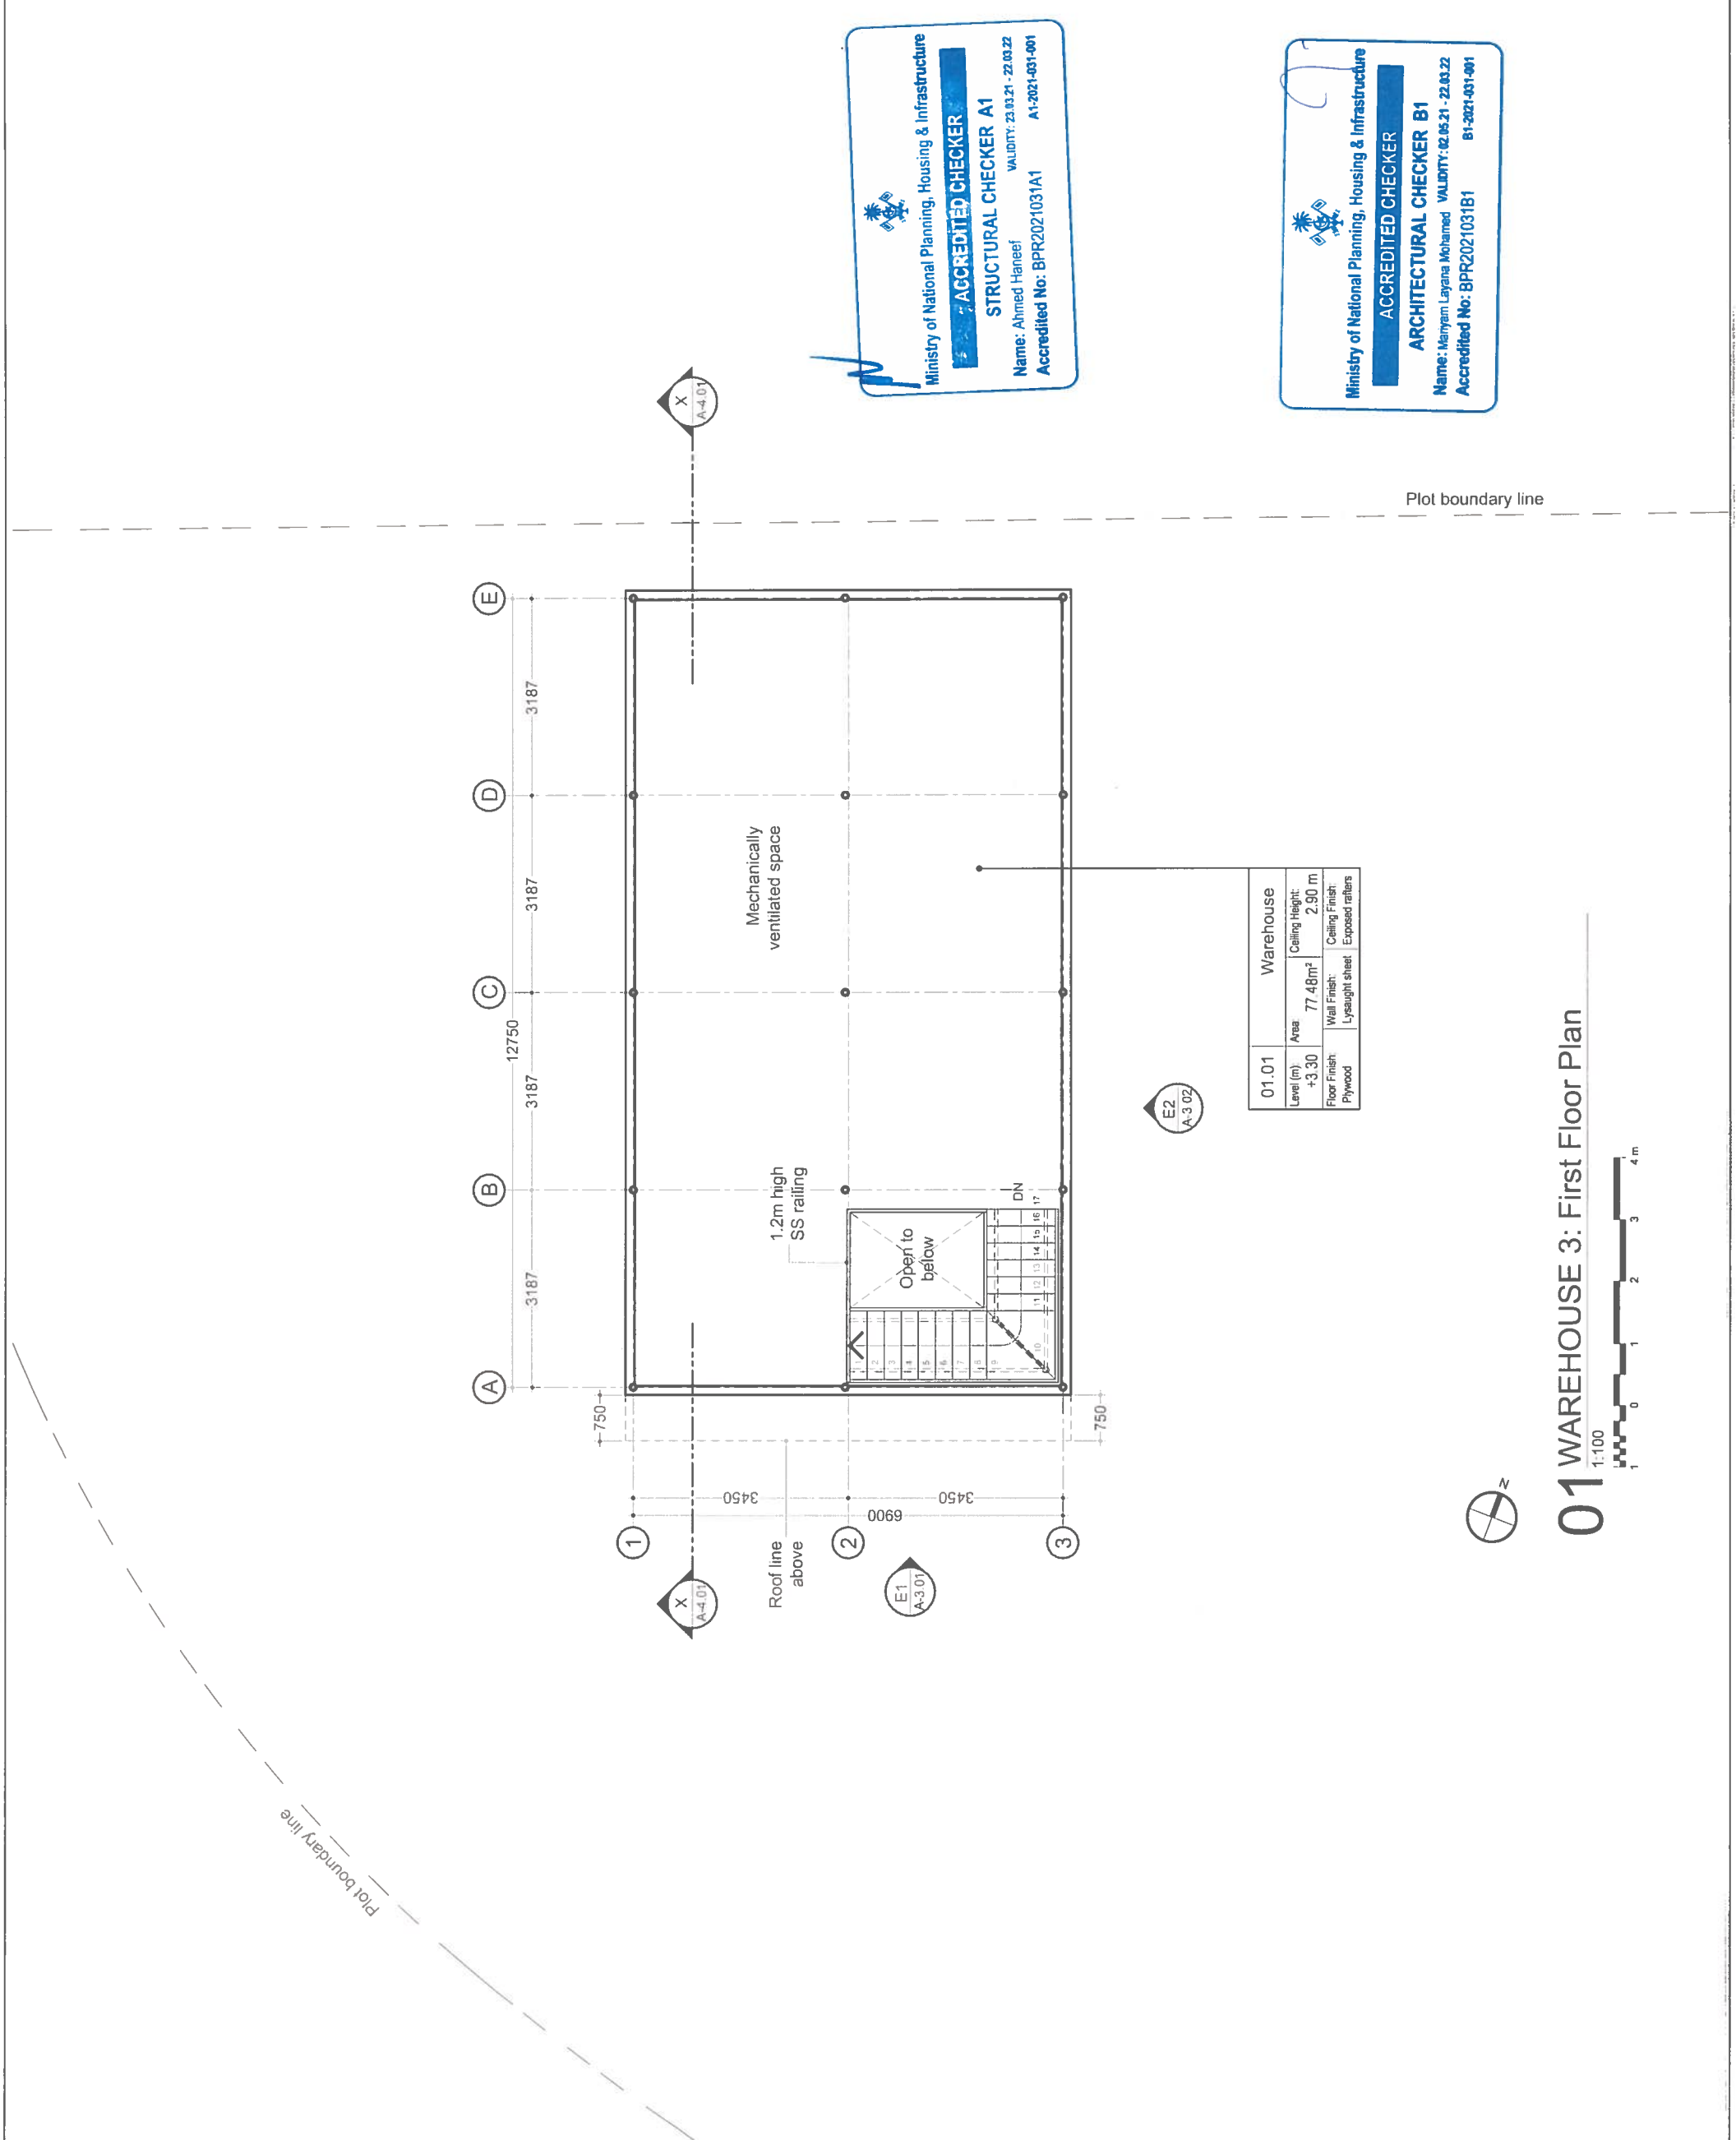

Warehouse			
01.01	Level (m)	+3.30	Ceiling Height: 2.90 m
	Area	77.48m ²	
	Floor Finish:	Plywood	Wall Finish:
		Lysaught sheet	Ceiling Finish:
			Exposed rafters

01 WAREHOUSE 3: First Floor Plan



GENERAL NOTES:

1. Do not scale drawings. Dimensions govern
2. All dimensions are in millimeters and all levels are in meters unless noted otherwise
3. All dimensions shall be verified on site before proceeding with work
4. Any areas indicated on this sheet are approximate and indicative only
5. Design Express shall be notified in writing of any discrepancies

REV	DESCRIPTION	DATE
00	INCEPTION	21/04/2021

KEY PLAN



H. KAFURUTHOLHIGE, JANAVAREE MAGU
 MALE 20042, REPUBLIC OF MALDIVES
 ✉ info@designexpress.mv
 ☎ +960 777 5119 © Design Express 2021

CLIENT
 AASANDHA COMPANY LTD.


PROJECT
 PROPOSED TWO STOREY WAREHOUSE 3 AT PLOT #: S5-36
 K. THILAFUSHI

TITLE
 ROOF PLAN

DESIGN STAGE
 CONCEPT DESIGN
 DESIGN DEVELOPMENT
 CONSTRUCTION DOCUMENTS
 AS-BUILT DRAWINGS

DRAWN BY	DESIGNED BY	CHECKED BY
DE	ISHA	LAYANA
DISCIPLINE	SHEET SIZE	SCALE
ARCHITECTURAL	A3	1:100
FIRST EMISSION	DRAWING NUMBER	REVISION
21/04/2021	A-2.04	00

UPDATE
 14/09/2021

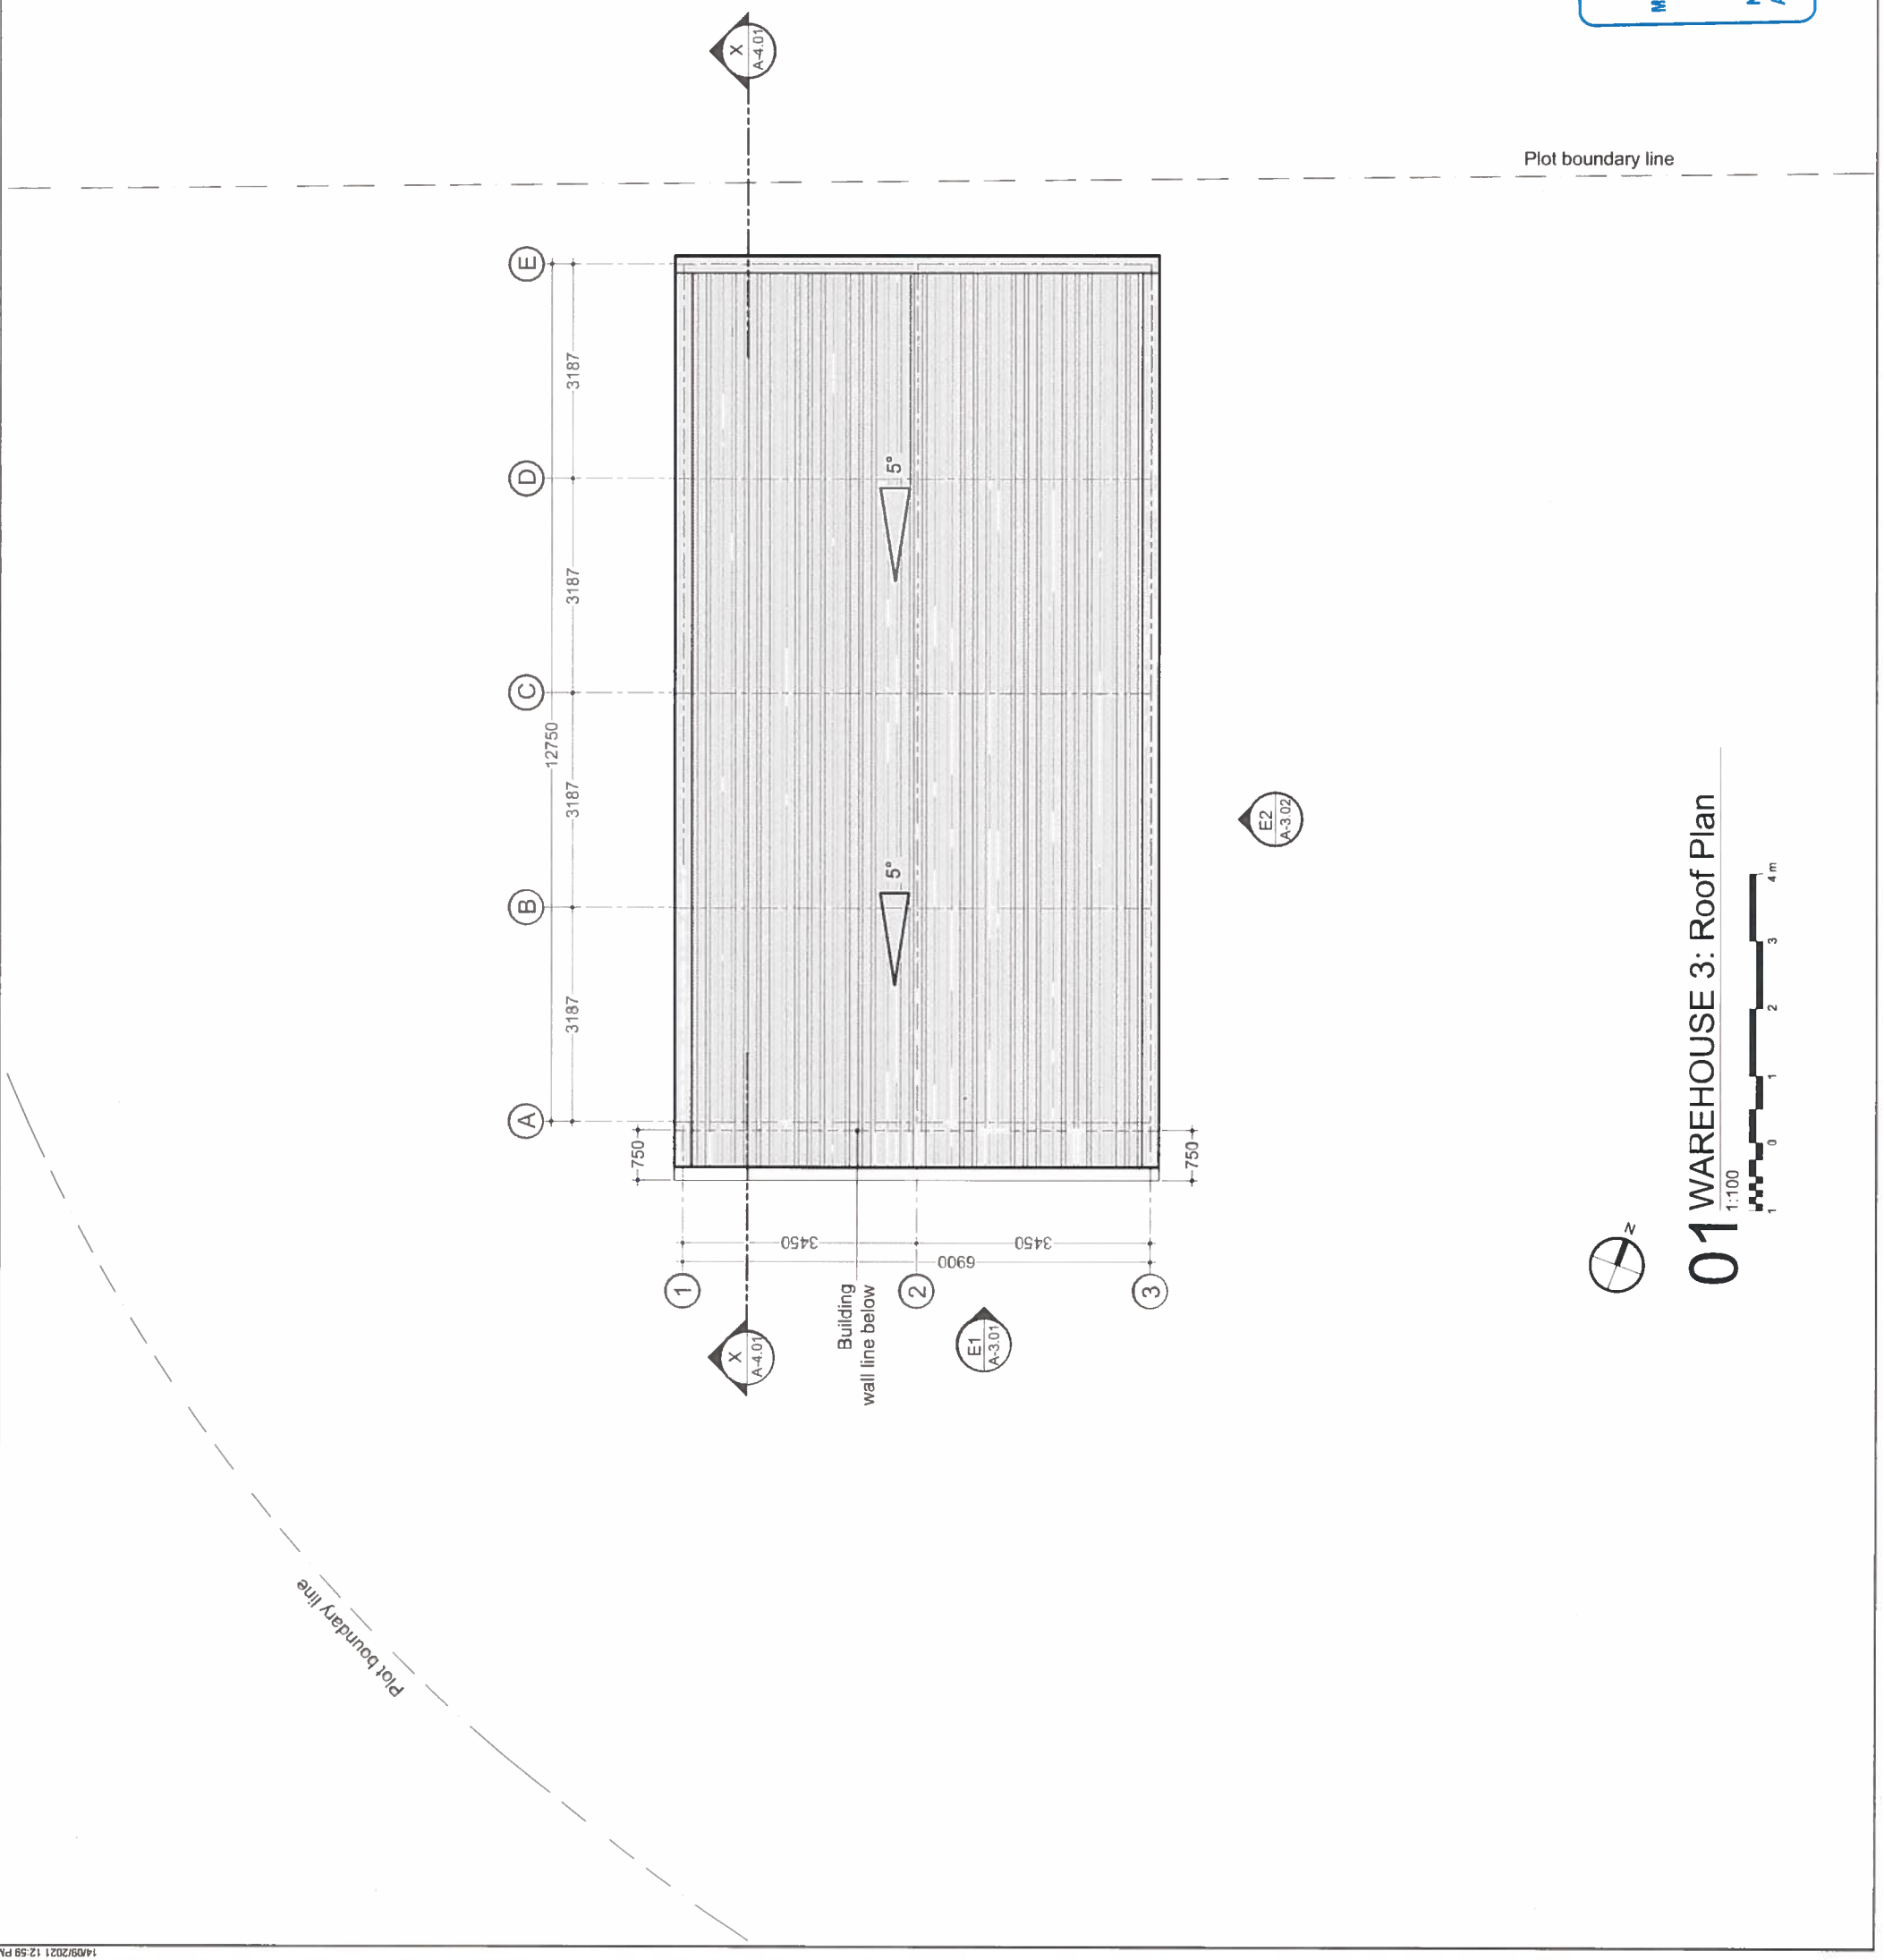

Ministry of National Planning, Housing & Infrastructure

ACCREDITED CHECKER

ARCHITECTURAL CHECKER B1

Name: Mariyam Layana Mohamed VALIDITY: 02.05.21 - 22.03.22

Accredited No.: BPR2021031B1 B1:2021-031-001

Ministry of National Planning, Housing & Infrastructure

ACCREDITED CHECKER

STRUCTURAL CHECKER A1

Name: Ahmed Haneef VALIDITY: 23.03.21 - 22.03.22

Accredited No.: BPR2021031A1 A1:2021-031-001

01 WAREHOUSE 3: Roof Plan

1:100

0 1 2 3 4 m