


**GR FLOOR PLAN**

**PROJECT DETAILS**

PROJECT NAME:	COUNCIL HIYA
CLIENT DETAILS:	INGURAIIDHOO COUNCIL

**DRAWING DETAILS**

GR FLR ELEC. PLAN	A01
1:100	
DATE: July 2024	
SHEET NO:	

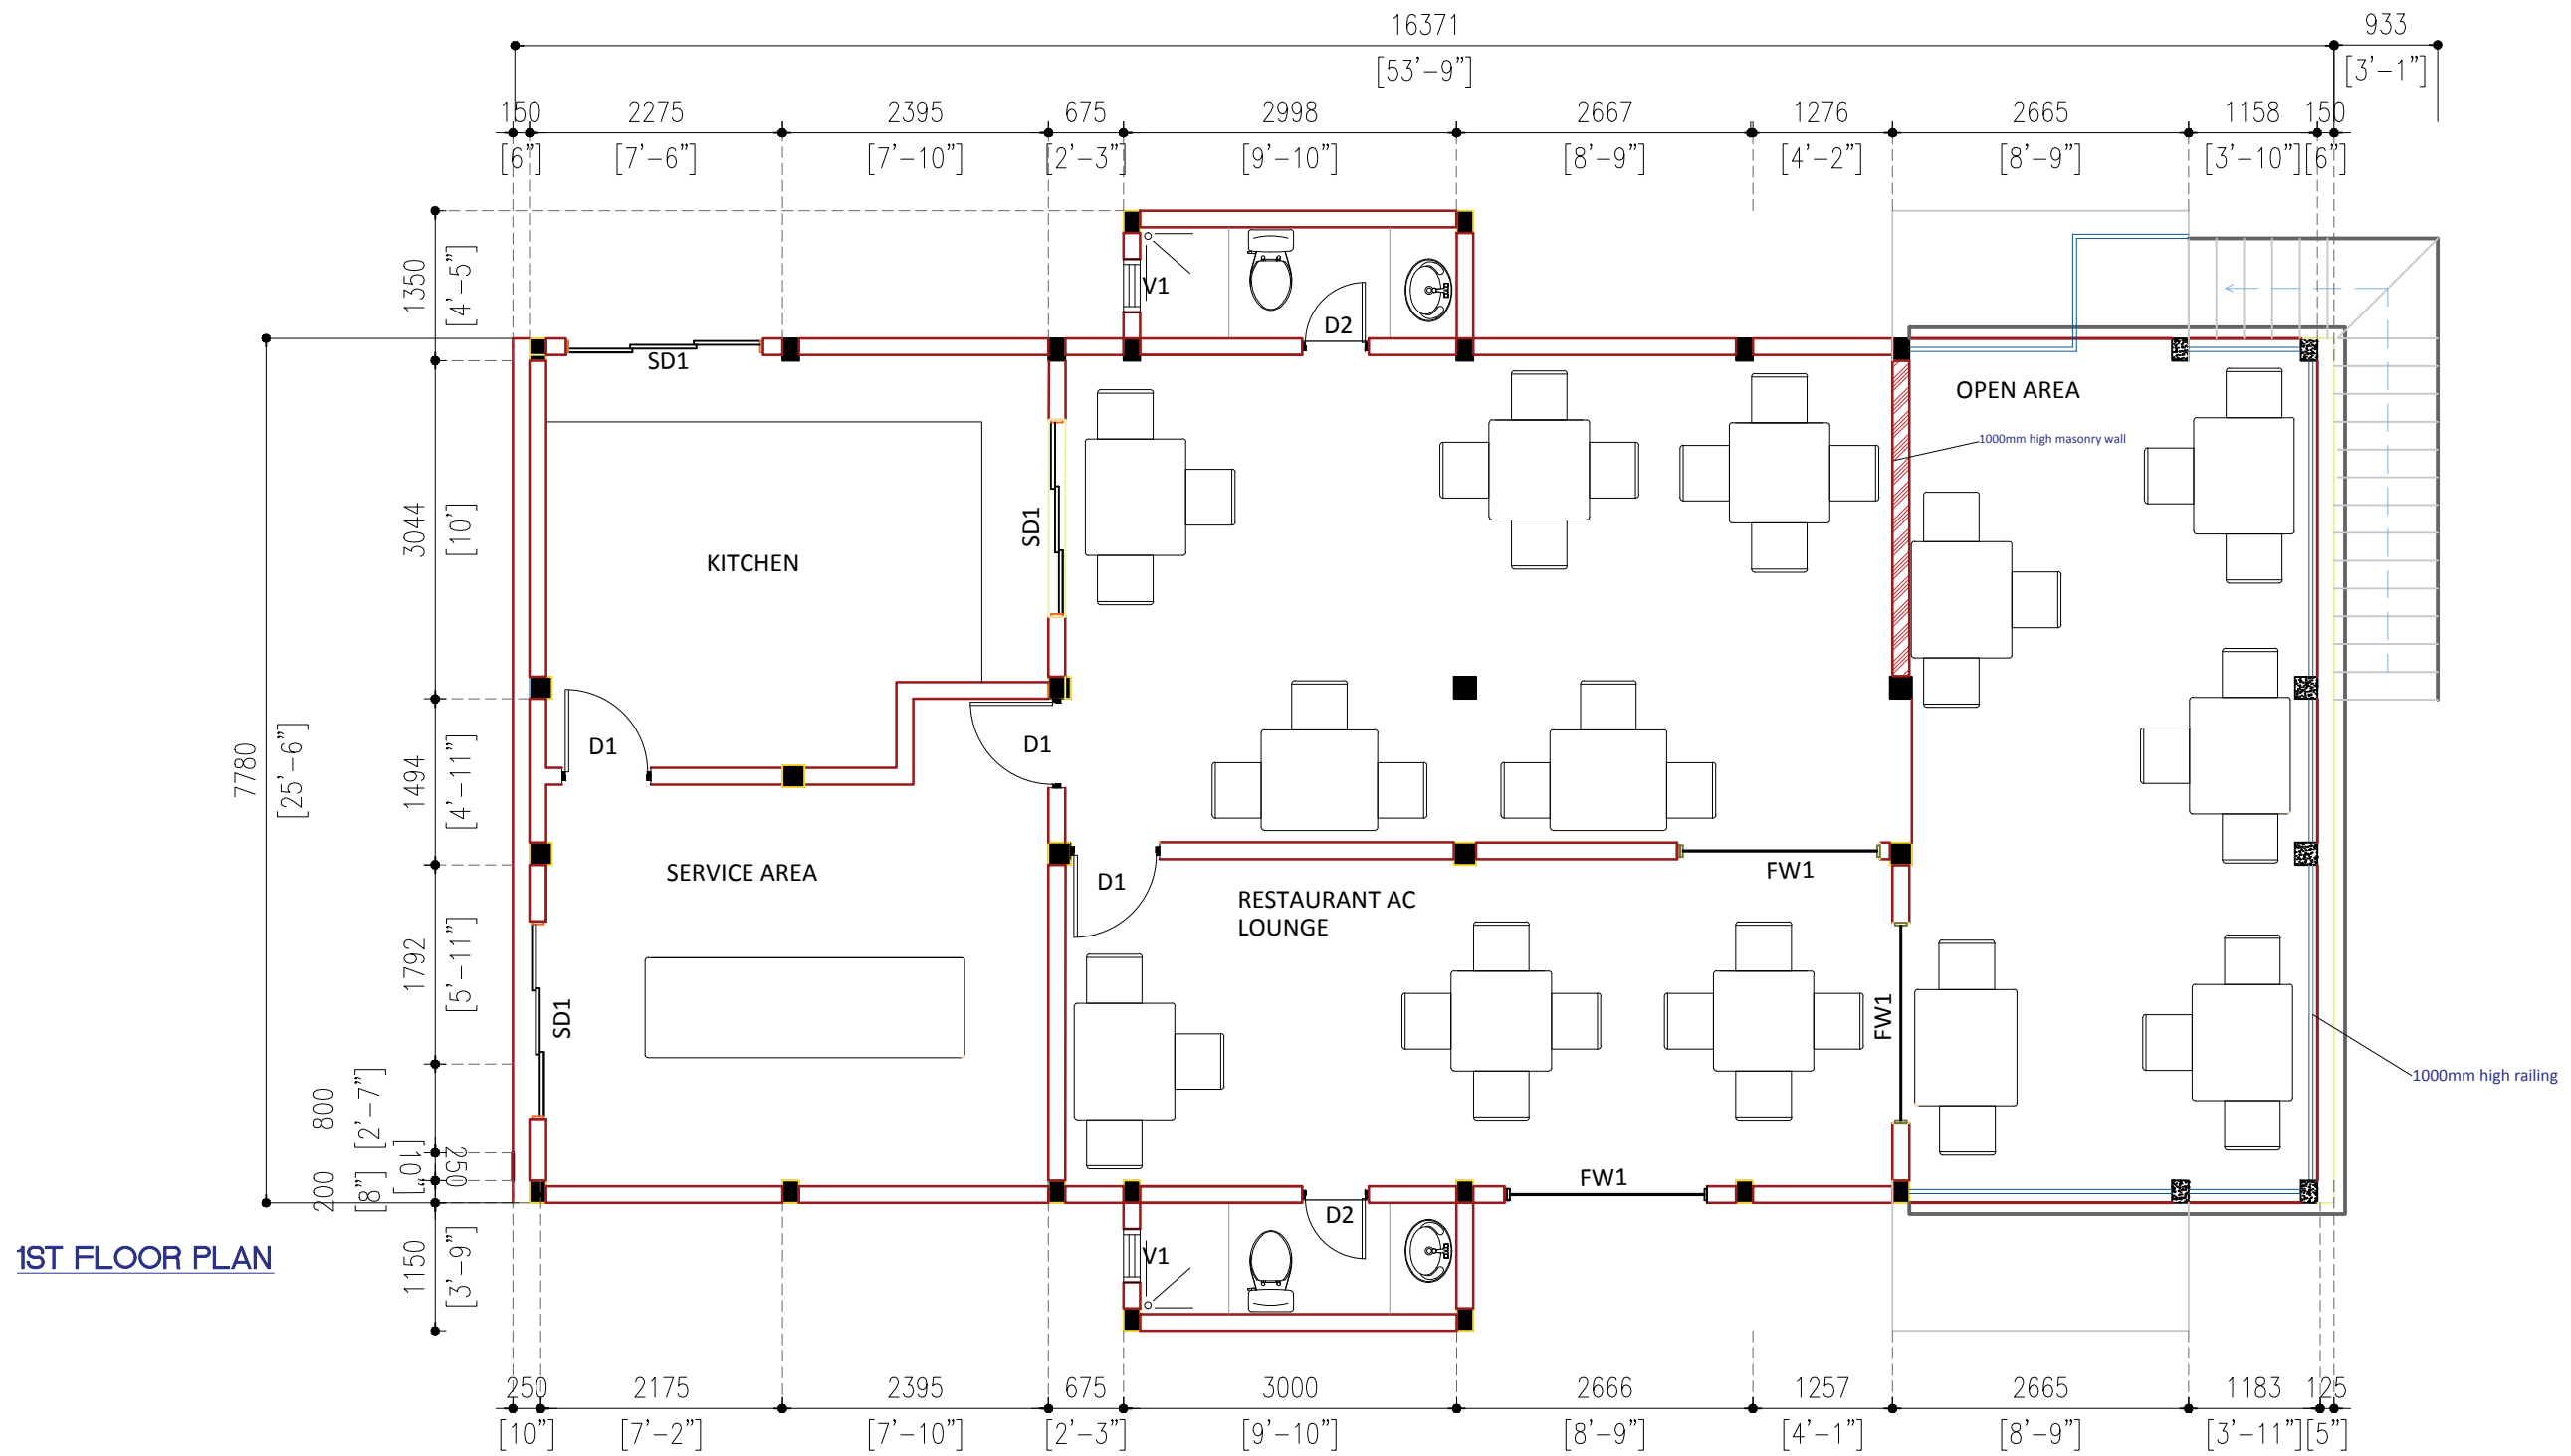

PROJECT DETAILS	
PROJECT NAME:	<b>COUNCIL HIYA</b>
CLIENT DETAILS:	<b>INGURAIIDHOO COUNCIL</b>

DRAWING DETAILS	
1ST FLOOR PLAN	A02
1:100	
DATE: July 2024	
SHEET NO:	




PROJECT DETAILS

PROJECT NAME:	<b>COUNCIL HIYA</b>
CLIENT DETAILS:	<b>INGURAIIDHOO COUNCIL</b>



DRAWING DETAILS

<b>FOUNDATION PLAN</b>	<b>A03</b>
1:100	
DATE: July 2024	
SHEET NO:	


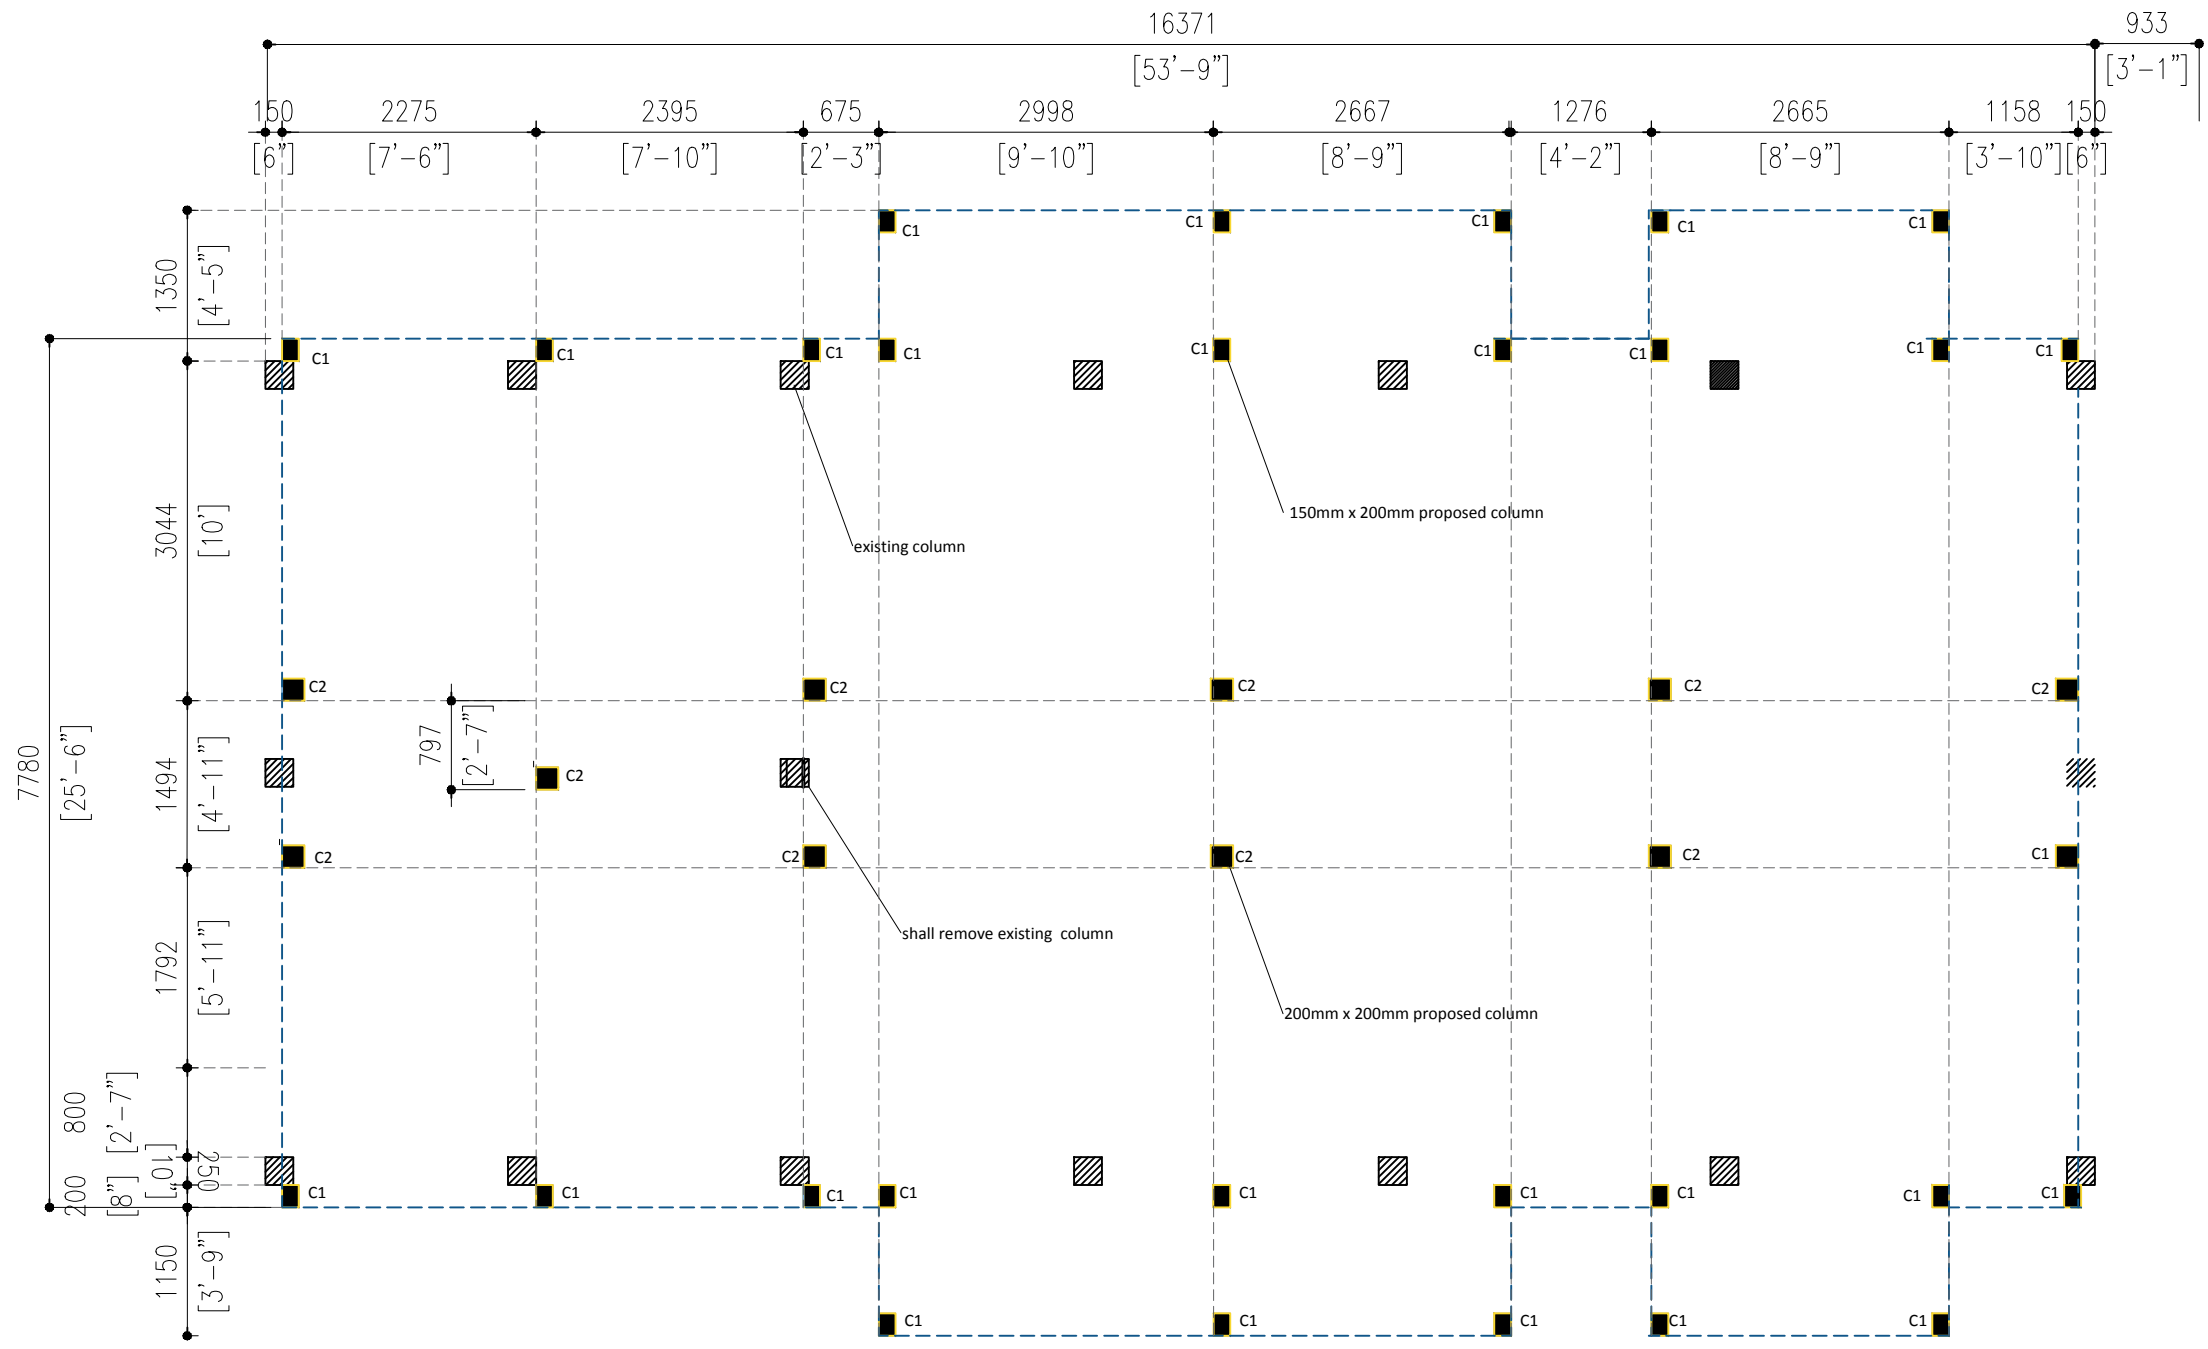


**COLUMN PLAN**

existing columns

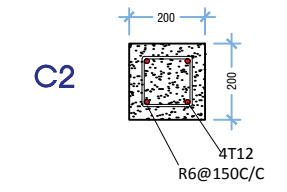
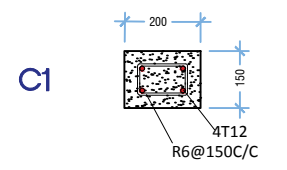


PROJECT DETAILS		DRAWING DETAILS	
PROJECT NAME:	<b>COUNCIL HIYA</b>	COLUMN PLAN	1:100
CLIENT DETAILS:	<b>INGURAIIDHOO COUNCIL</b>	DATE: July 2024	A04
		SHEET NO:	

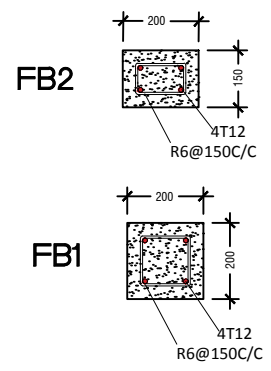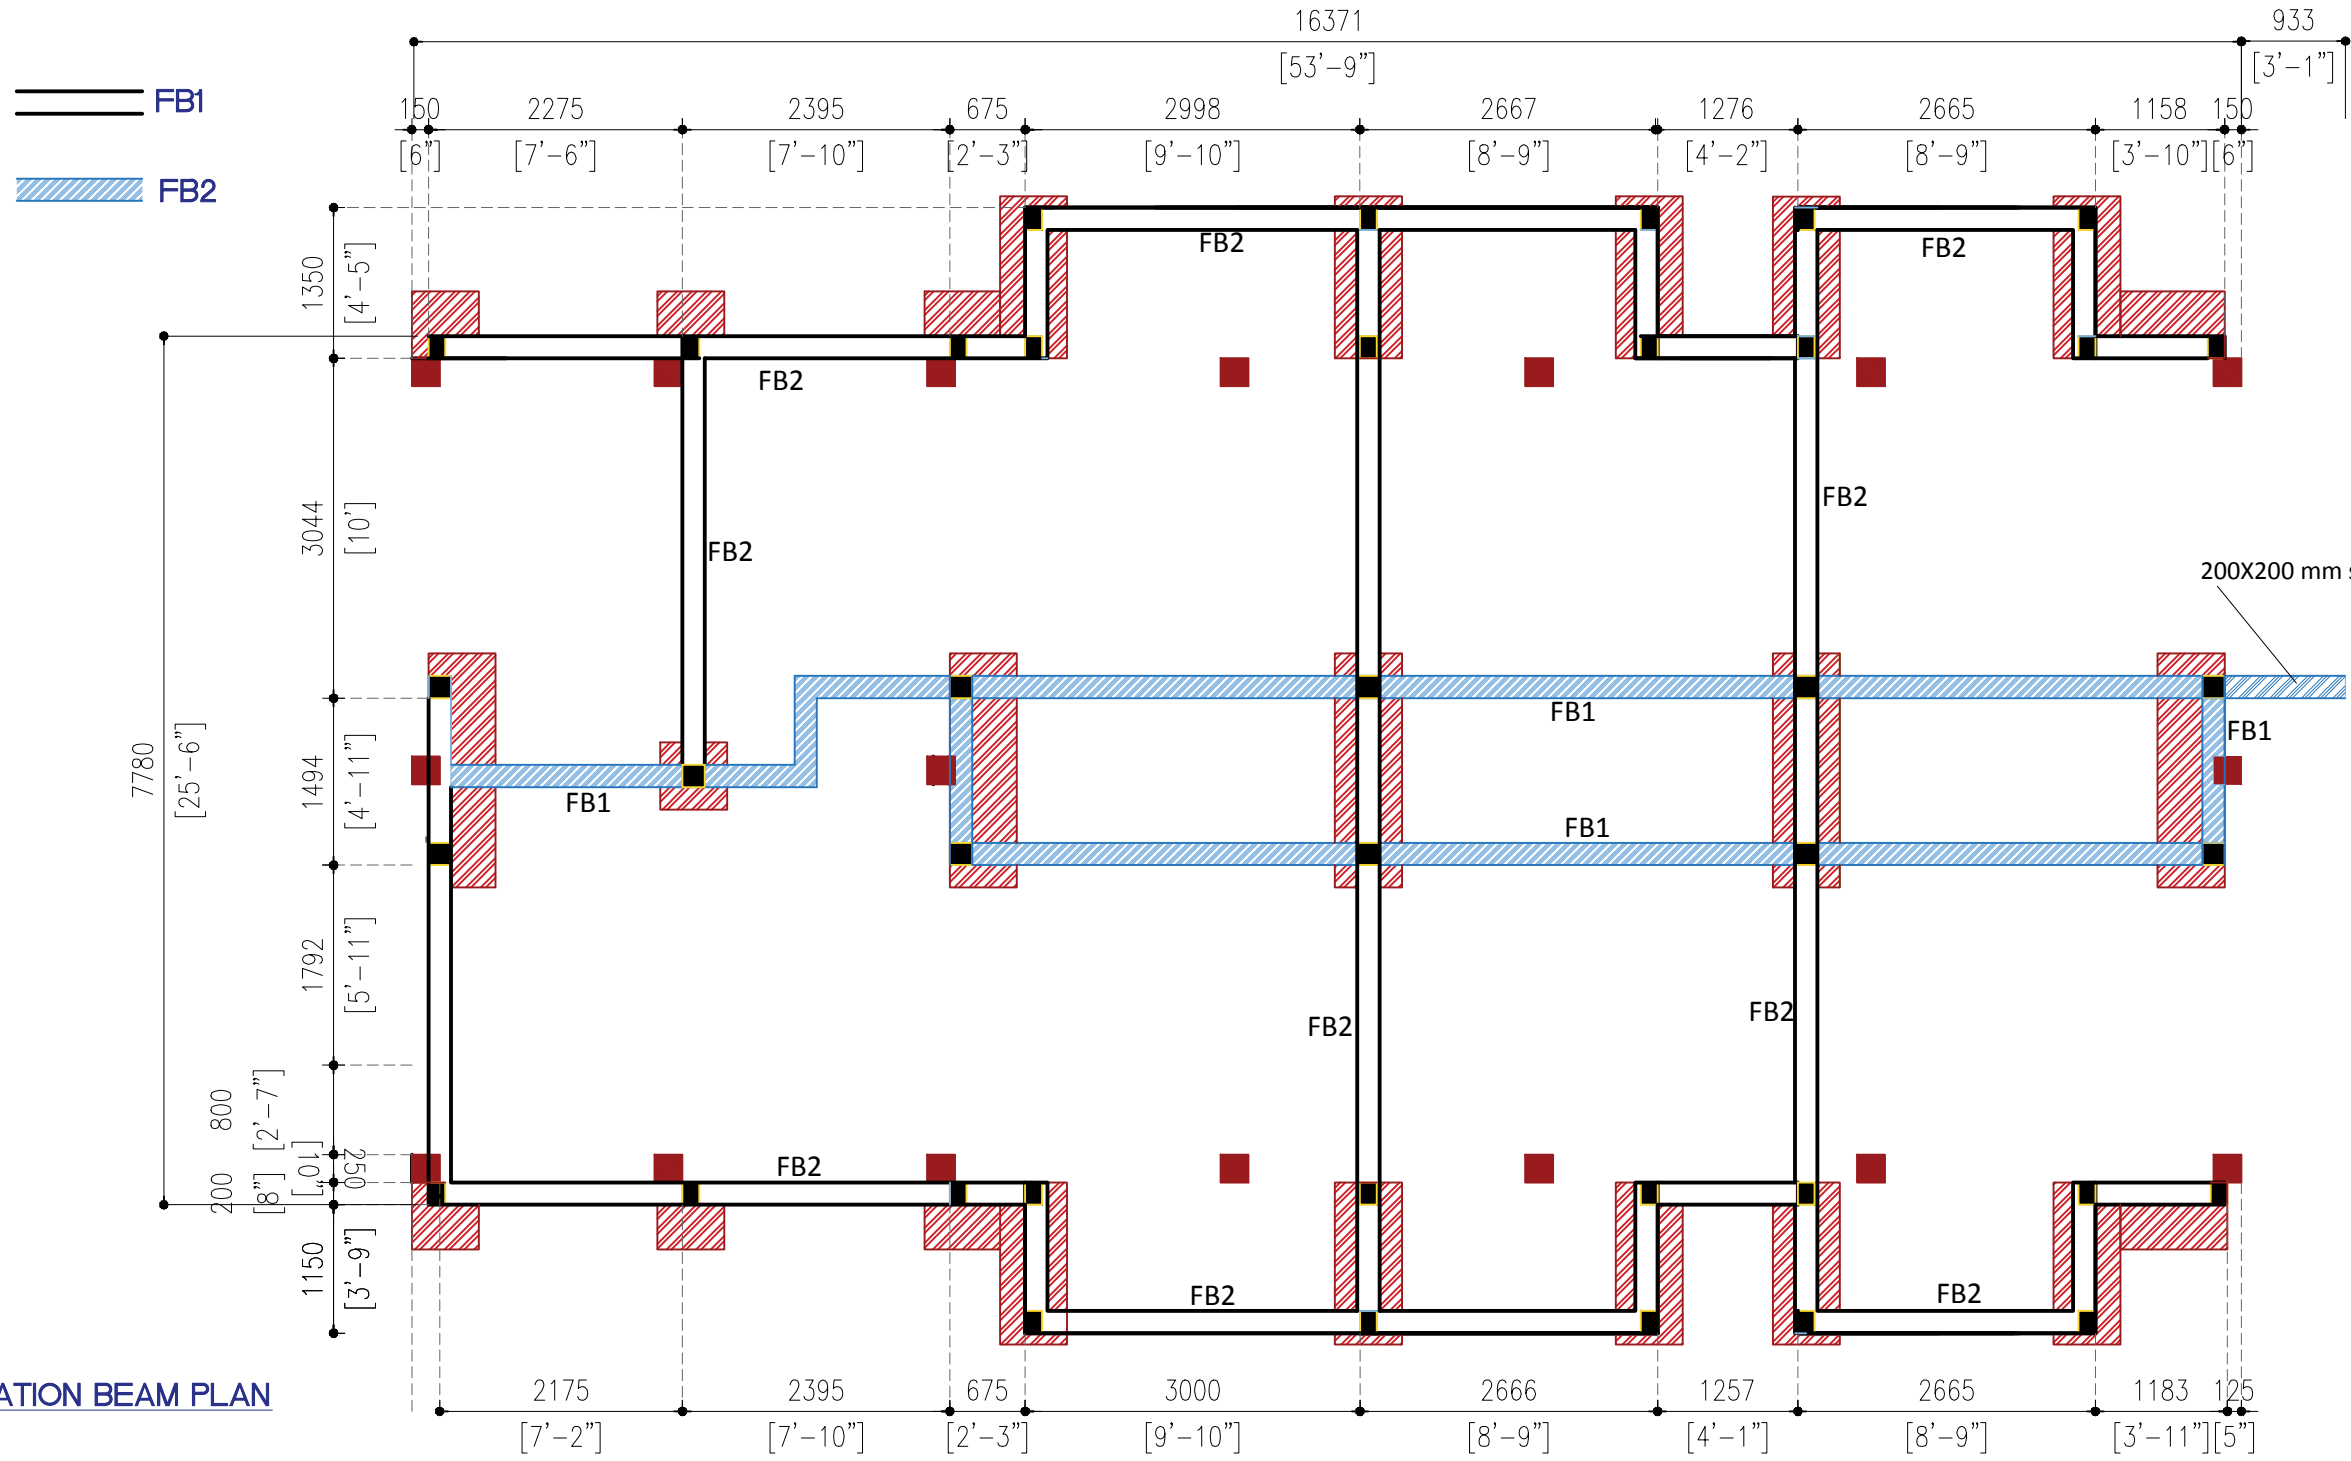

**FOUNDATION BEAM PLAN**

PROJECT DETAILS		DRAWING DETAILS	
PROJECT NAME:	COUNCIL HIYA	FOUNDATION BEAM PLAN	1:100
CLIENT DETAILS:	INGURAIIDHOO COUNCIL	DATE: July 2024	A05
		SHEET NO:	

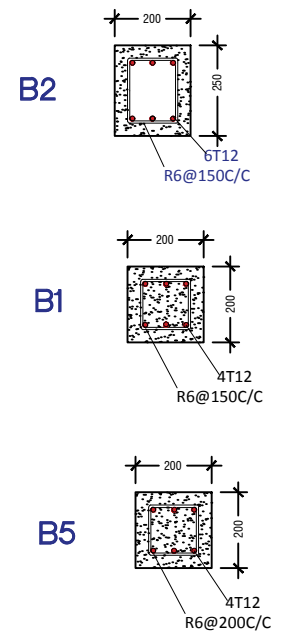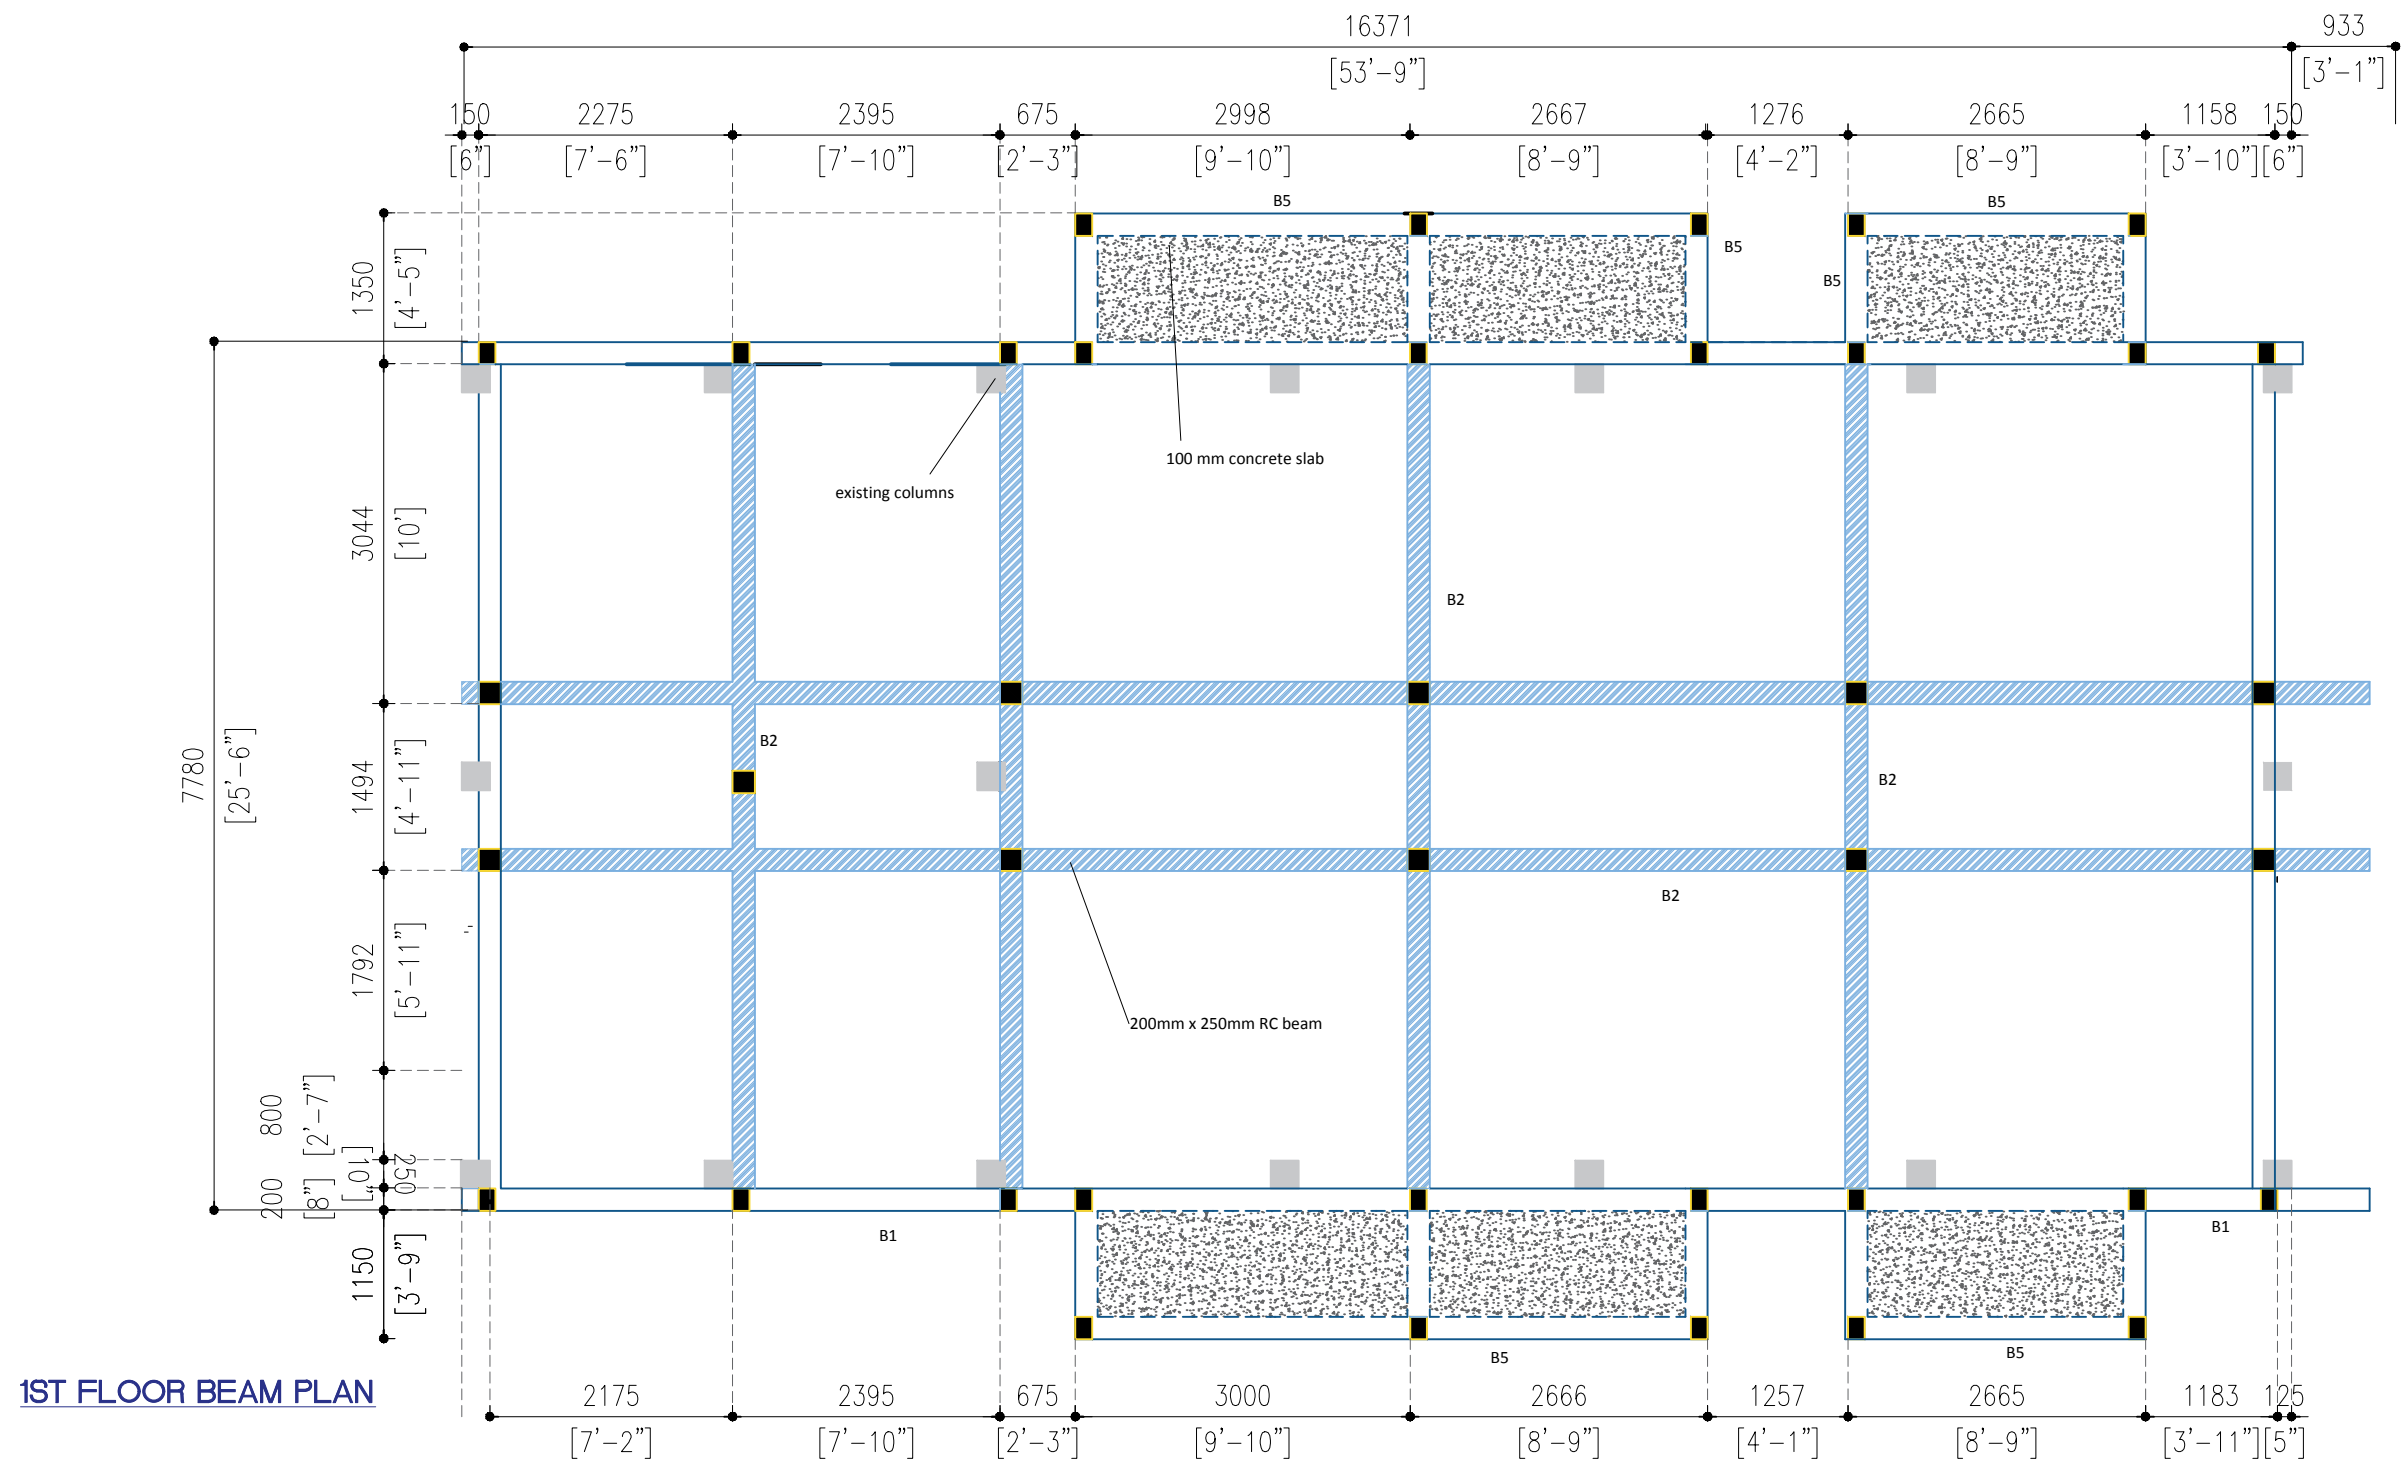


**PROJECT DETAILS**

PROJECT NAME:	<b>COUNCIL HIYA</b>
CLIENT DETAILS:	<b>INGURAIIDHOO COUNCIL</b>

**DRAWING DETAILS**

<b>1ST FLR BEAM PLAN</b>	<b>A06</b>
1:100	
DATE: July 2024	
SHEET NO:	

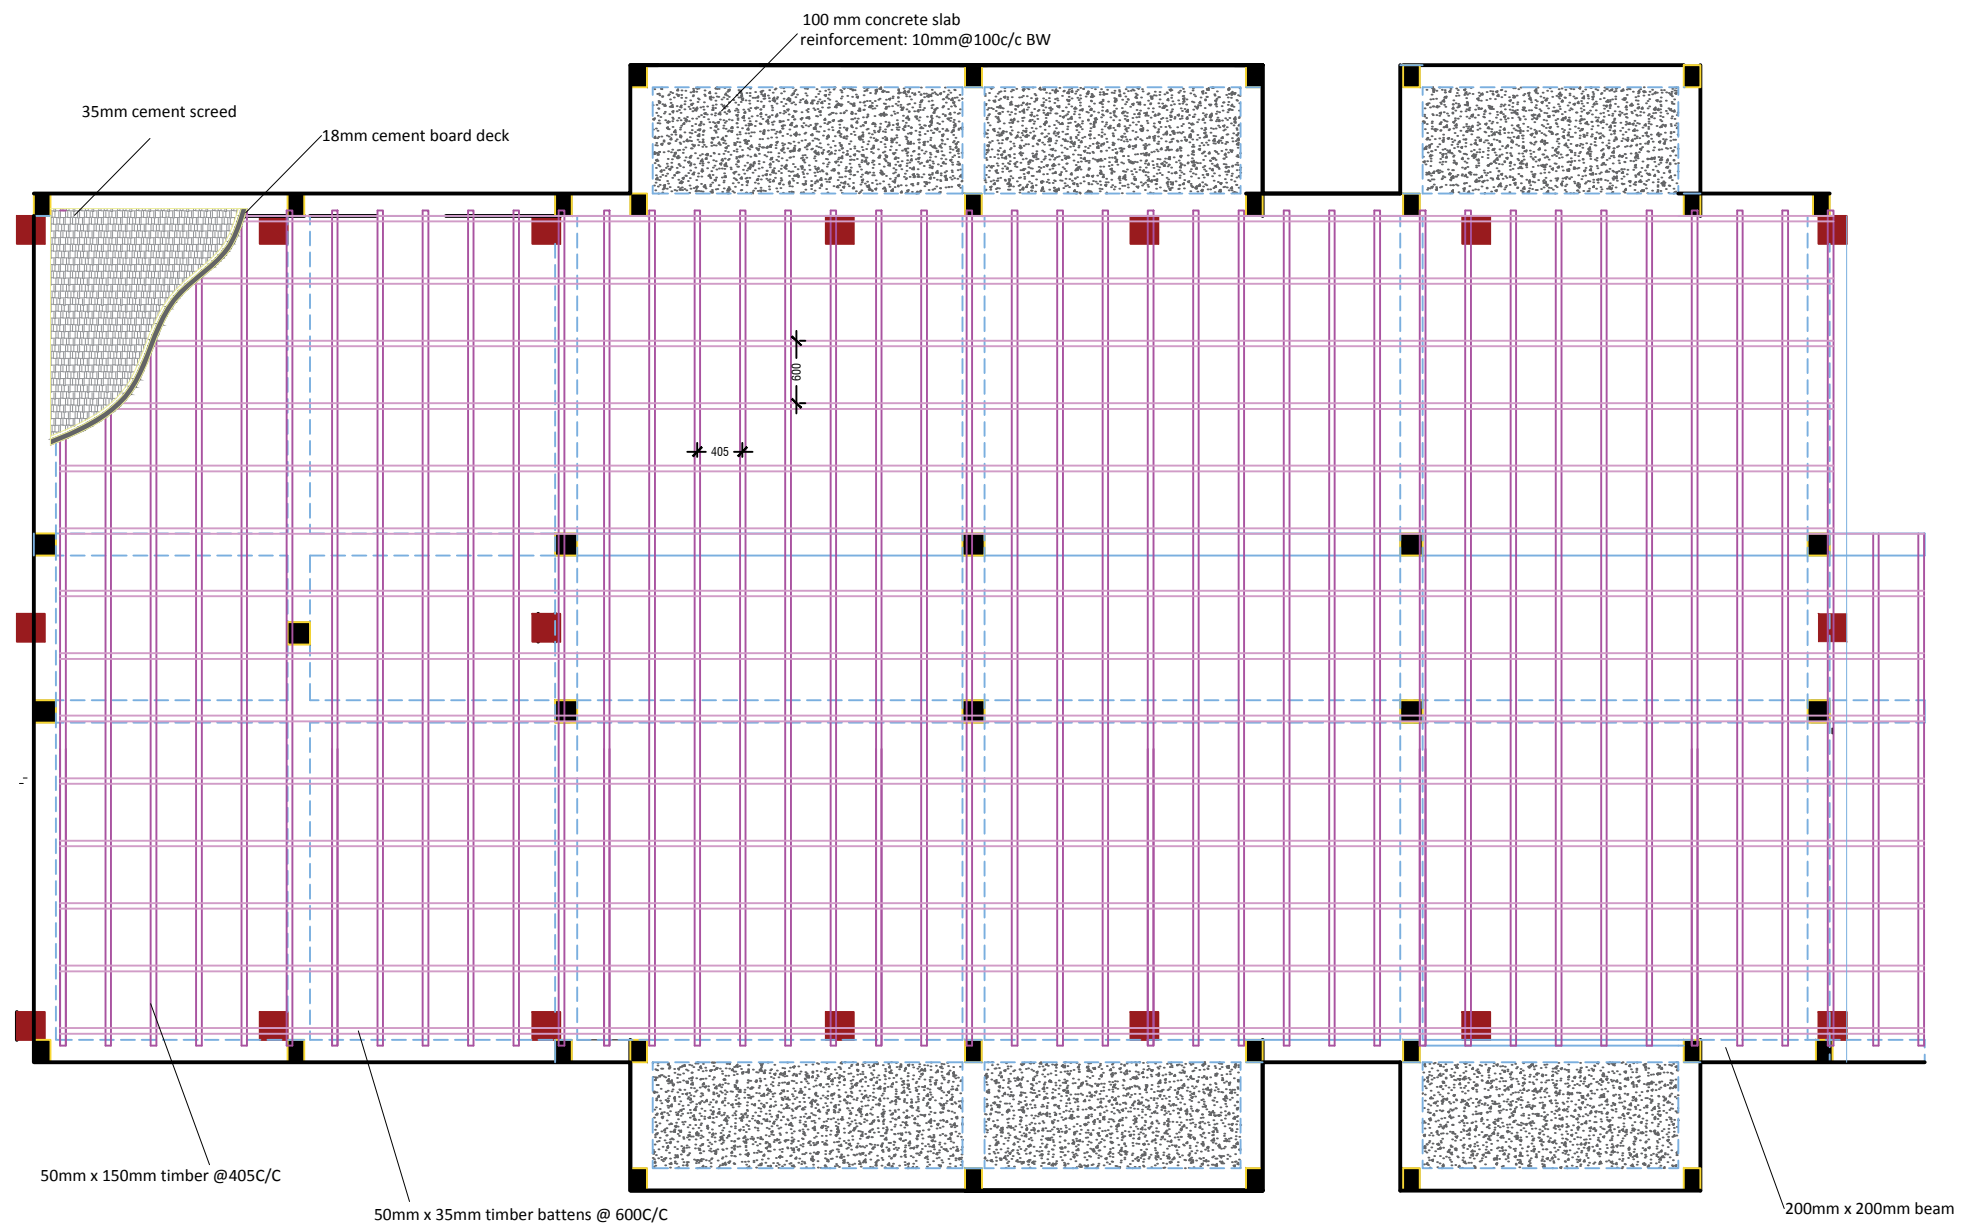

**DECK STRUCTURE PLAN**


PROJECT DETAILS

PROJECT NAME:	<b>COUNCIL HIYA</b>
CLIENT DETAILS:	<b>INGURAIIDHOO COUNCIL</b>

DRAWING DETAILS

<b>1ST FLR DECK STR. PLAN</b>	<b>A07</b>
1:100	
DATE: July 2024	
SHEET NO:	

**ROOF BEAM PLAN**

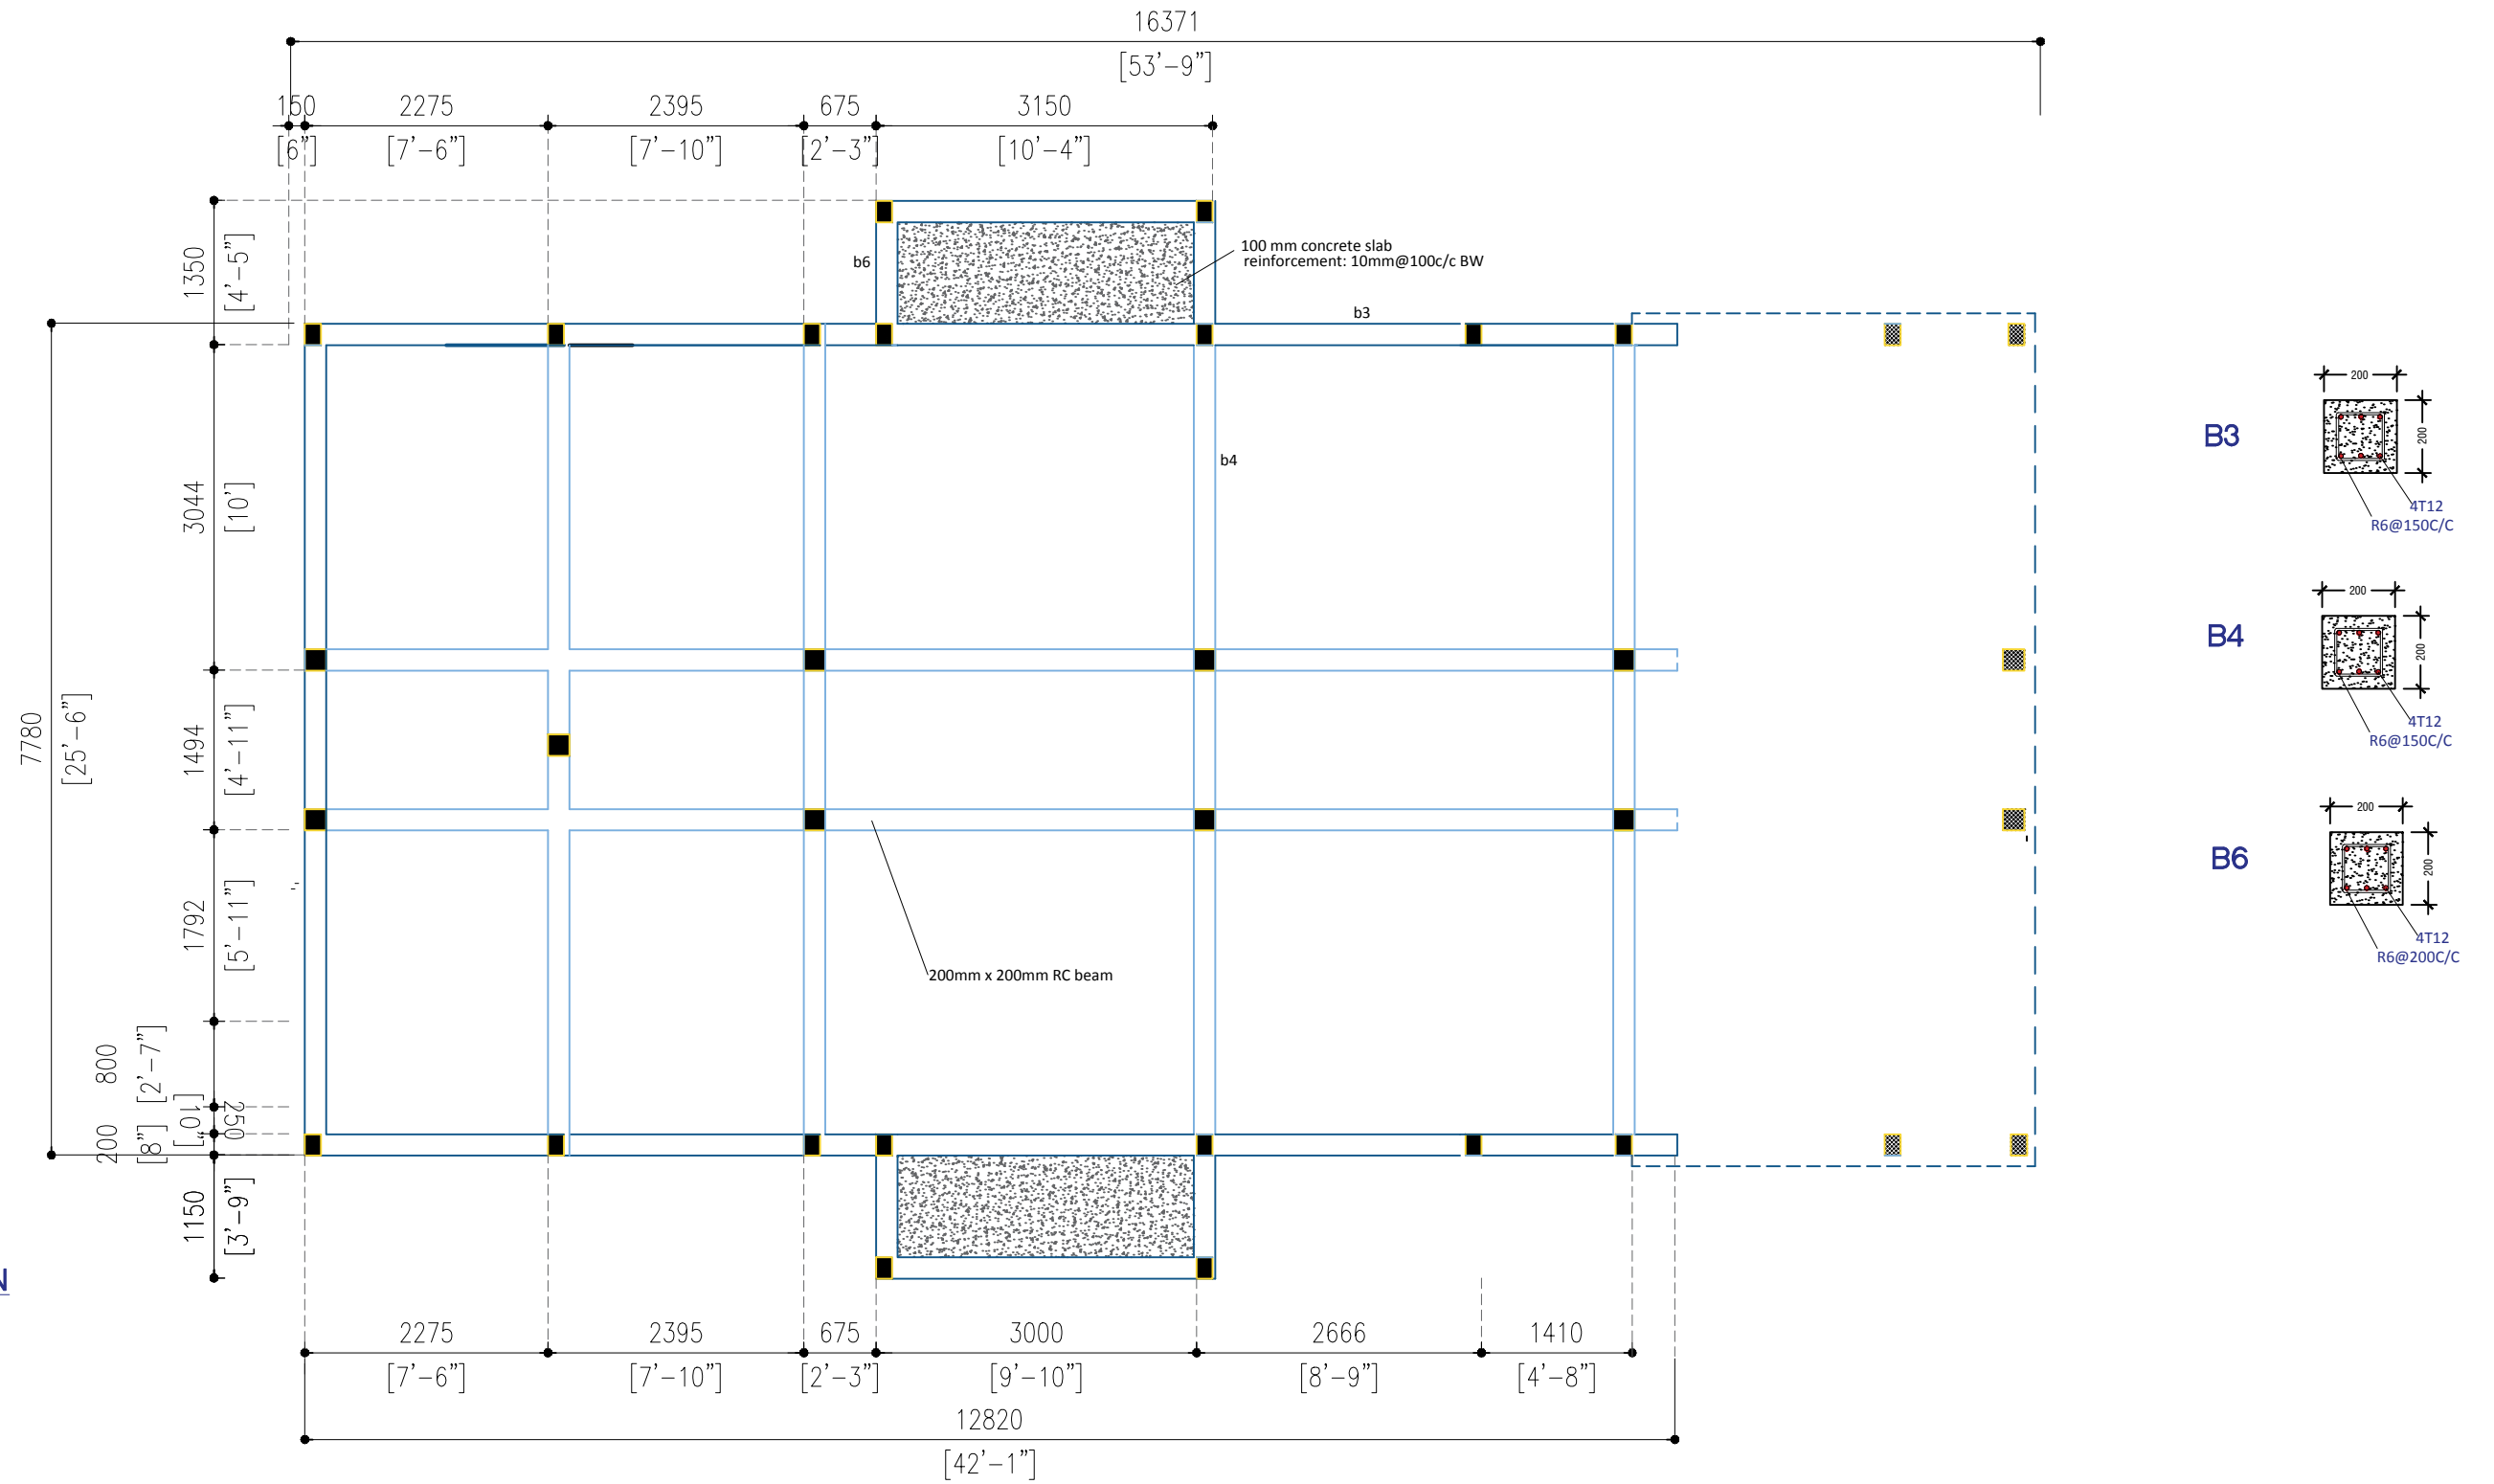

**PROJECT DETAILS**


PROJECT NAME:	<b>COUNCIL HIYA</b>
CLIENT DETAILS:	<b>INGURAIIDHOO COUNCIL</b>

**DRAWING DETAILS**

<b>ROOF BEAM PLAN</b>	<b>A08</b>
1:100	
DATE: July 2024	
SHEET NO:	



**ROOF PLAN**

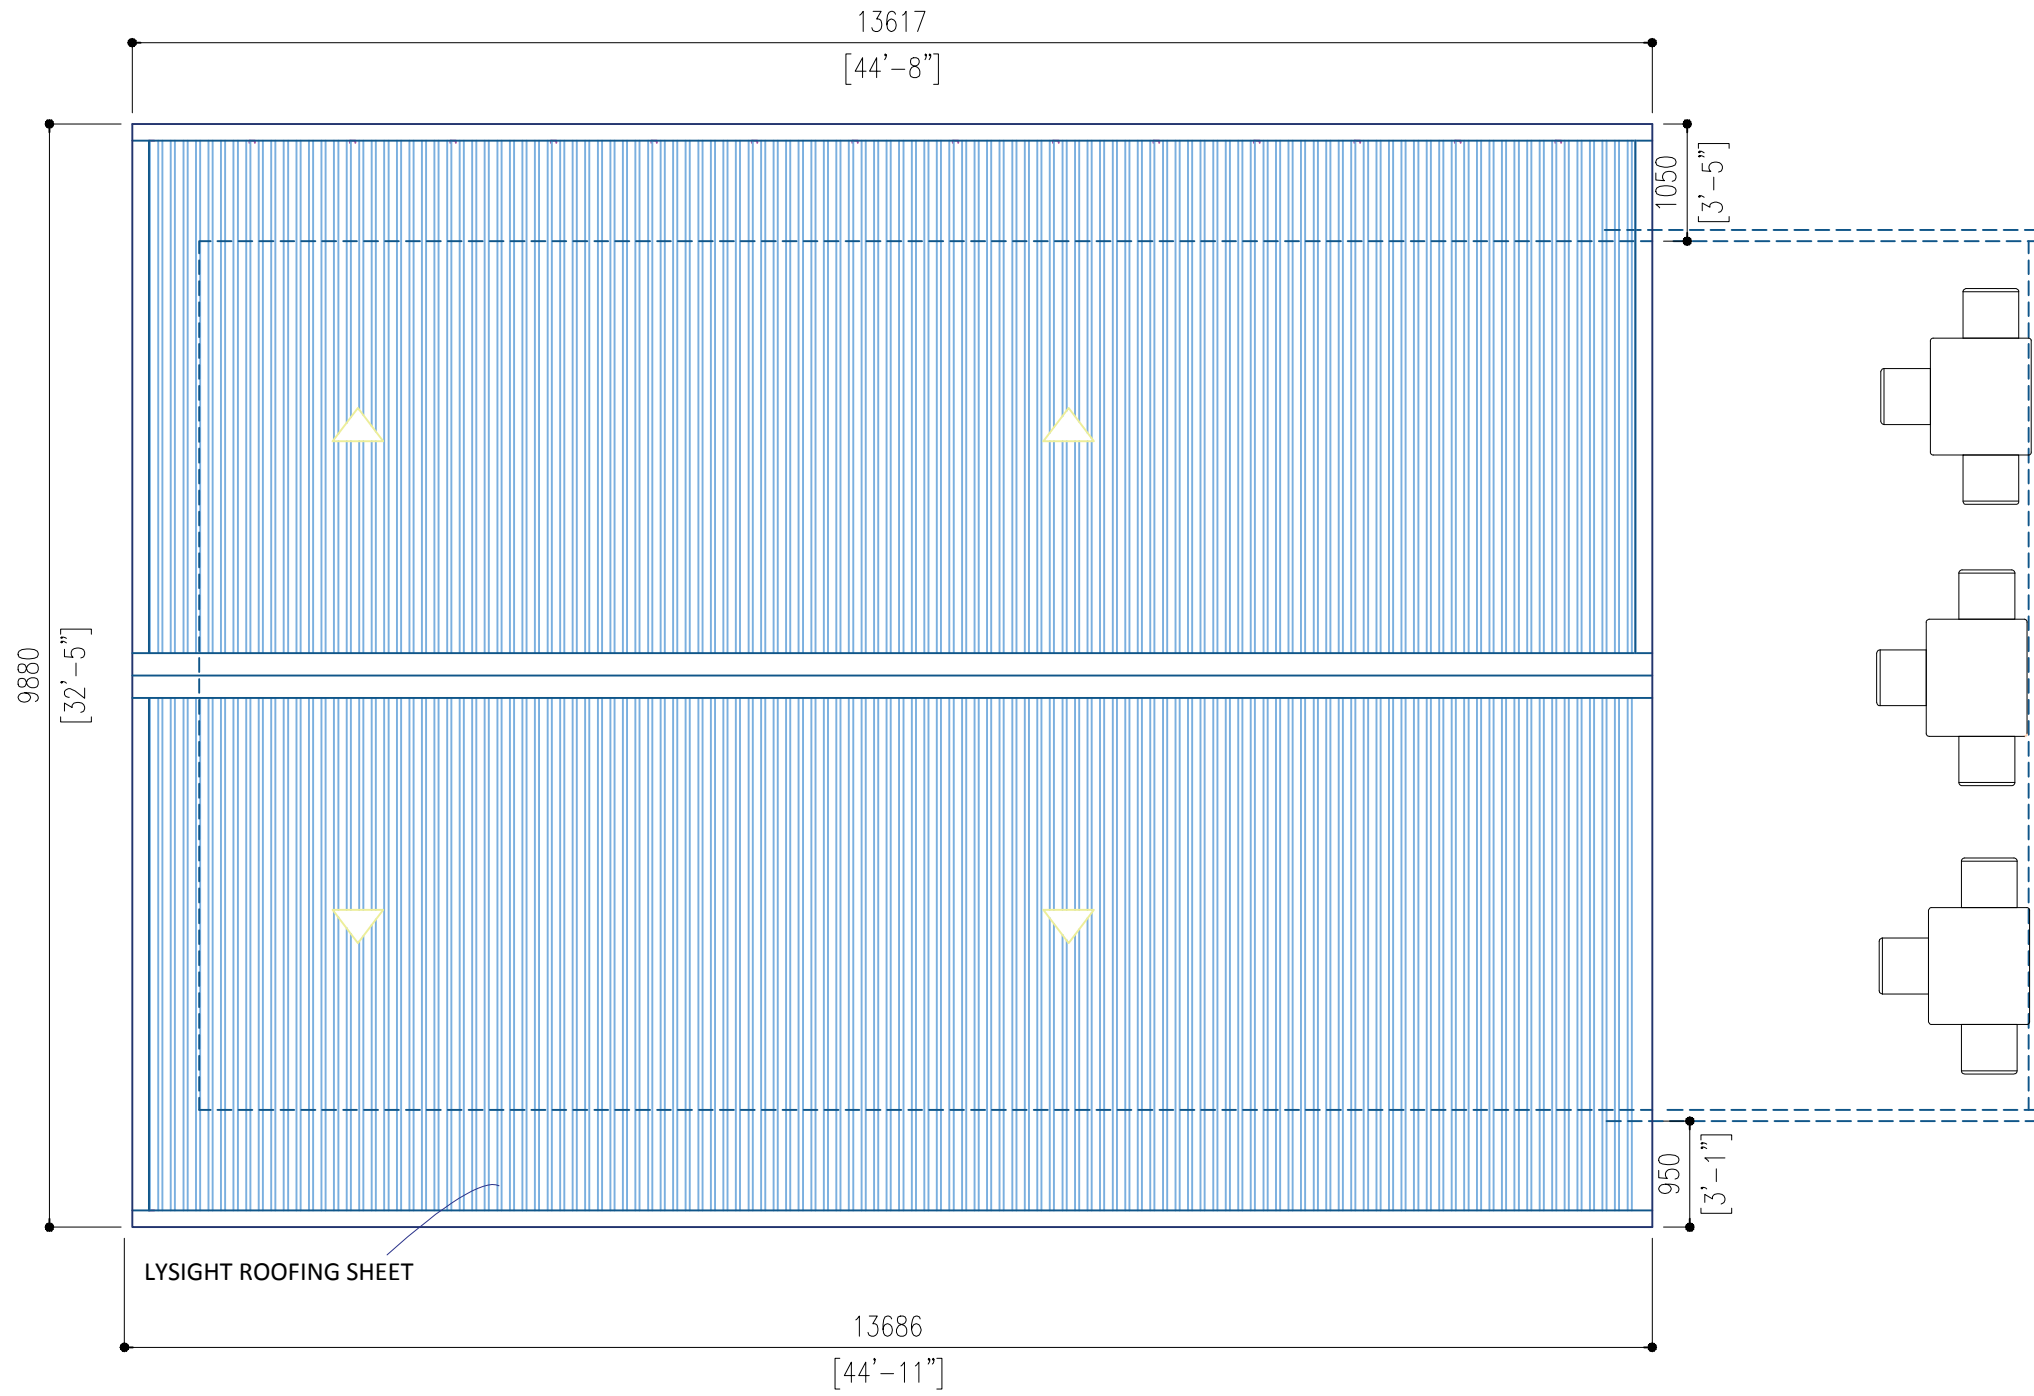


**PROJECT DETAILS**

PROJECT NAME:	<b>COUNCIL HIYA</b>
CLIENT DETAILS:	<b>INGURAIIDHOO COUNCIL</b>


**DRAWING DETAILS**

<b>ROOF PLAN</b> 1:100	A09
DATE: July 2024	
SHEET NO:	

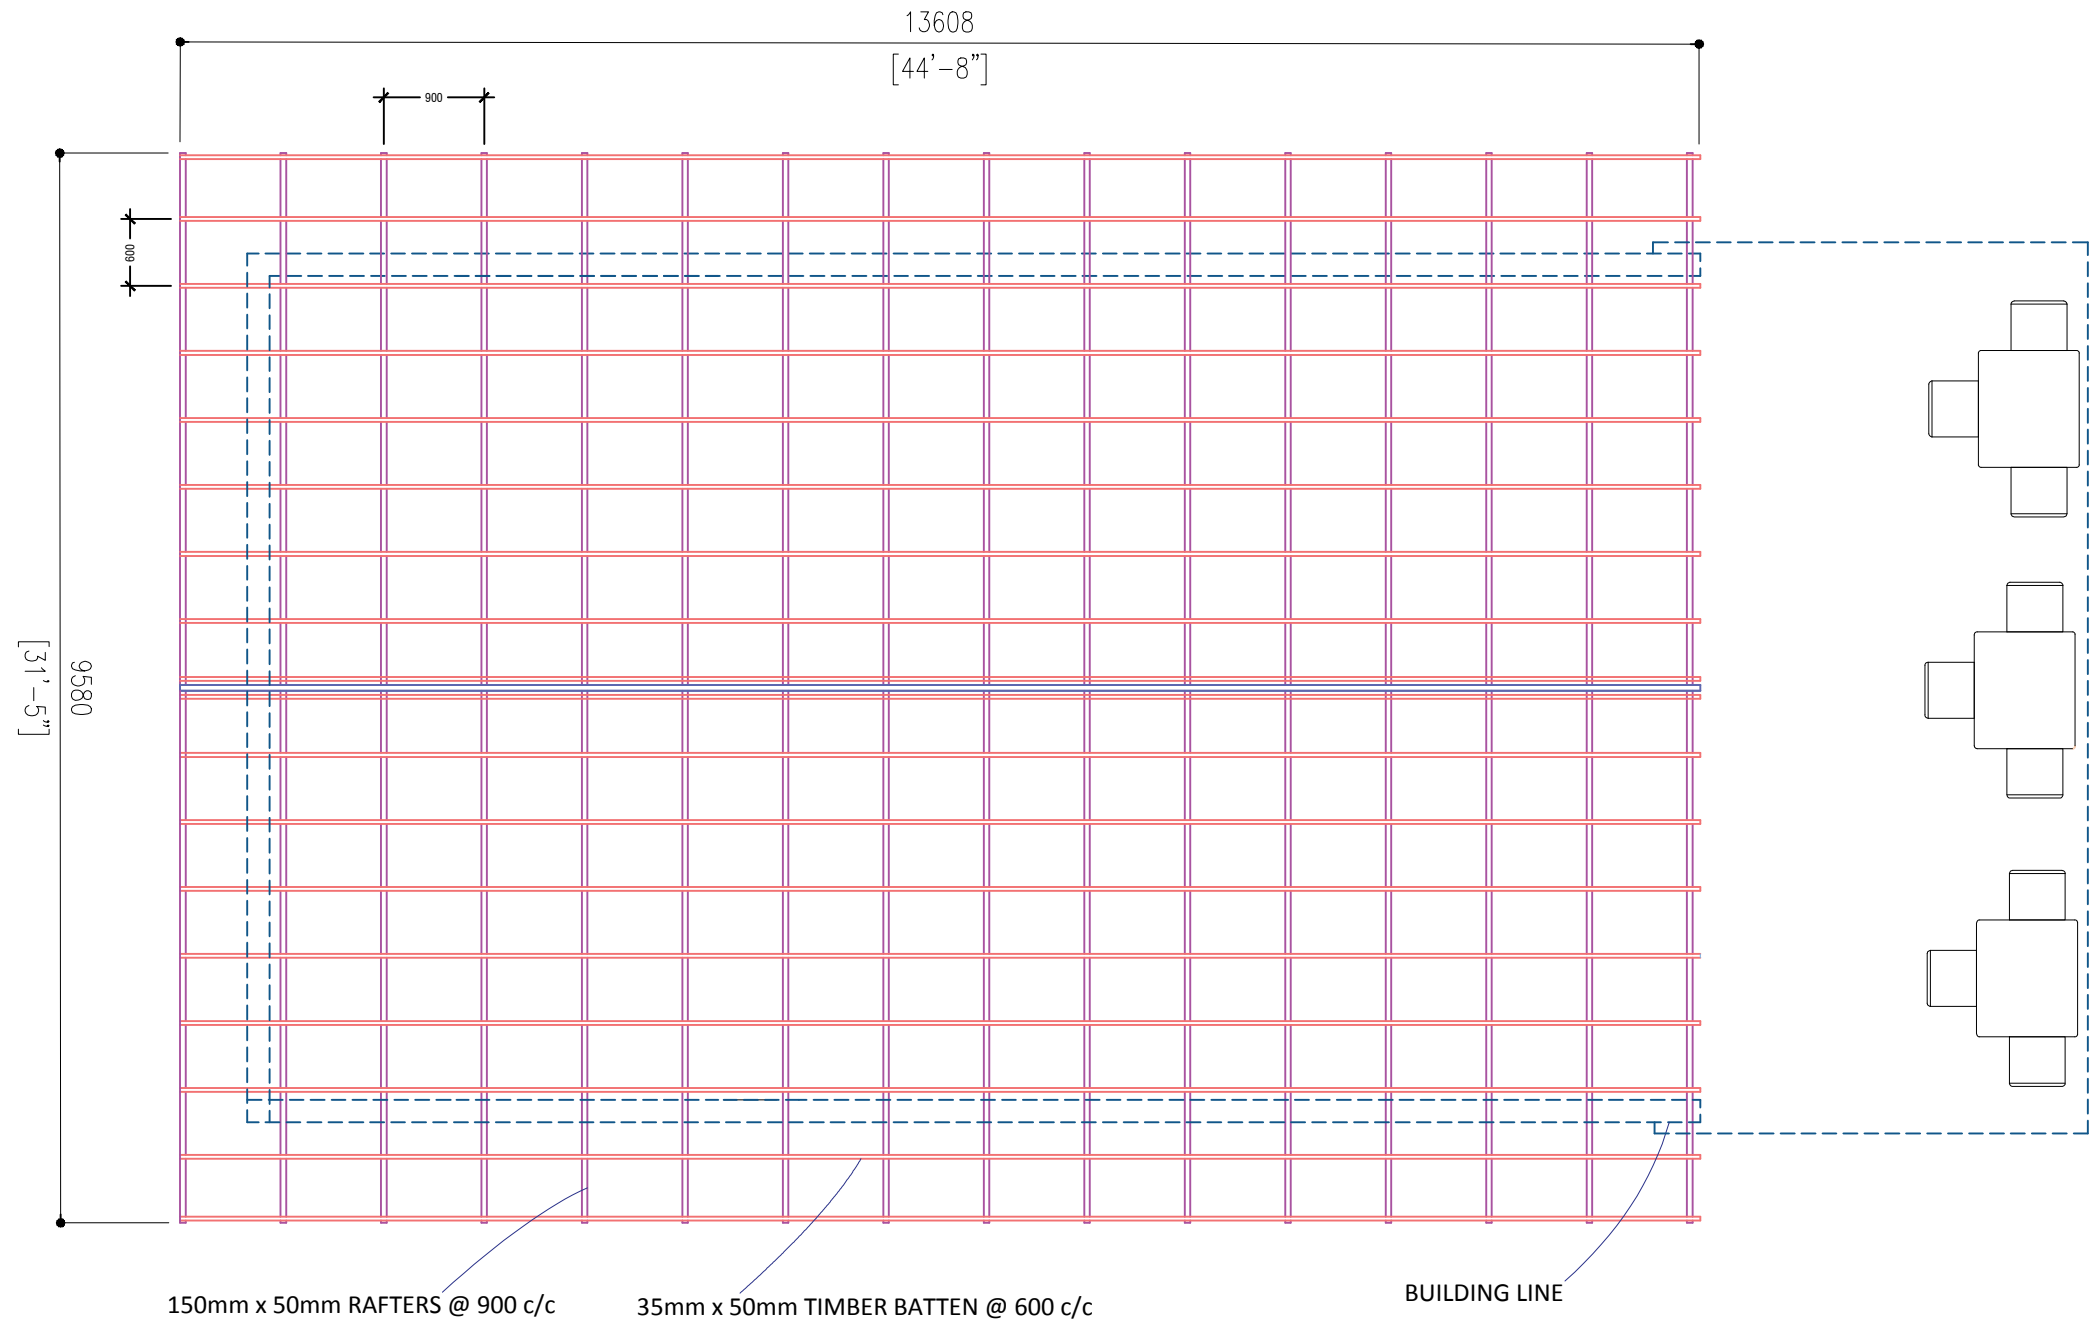

**ROOF STRUCTURE PLAN**

PROJECT DETAILS	DRAWING DETAILS
PROJECT NAME: <b>COUNCIL HIYA</b>	<b>GR FLR ELEC. PLAN</b> 1:100
CLIENT DETAILS: <b>INGURAIIDHOO COUNCIL</b>	DATE: July 2024
	SHEET NO: <b>A10</b>

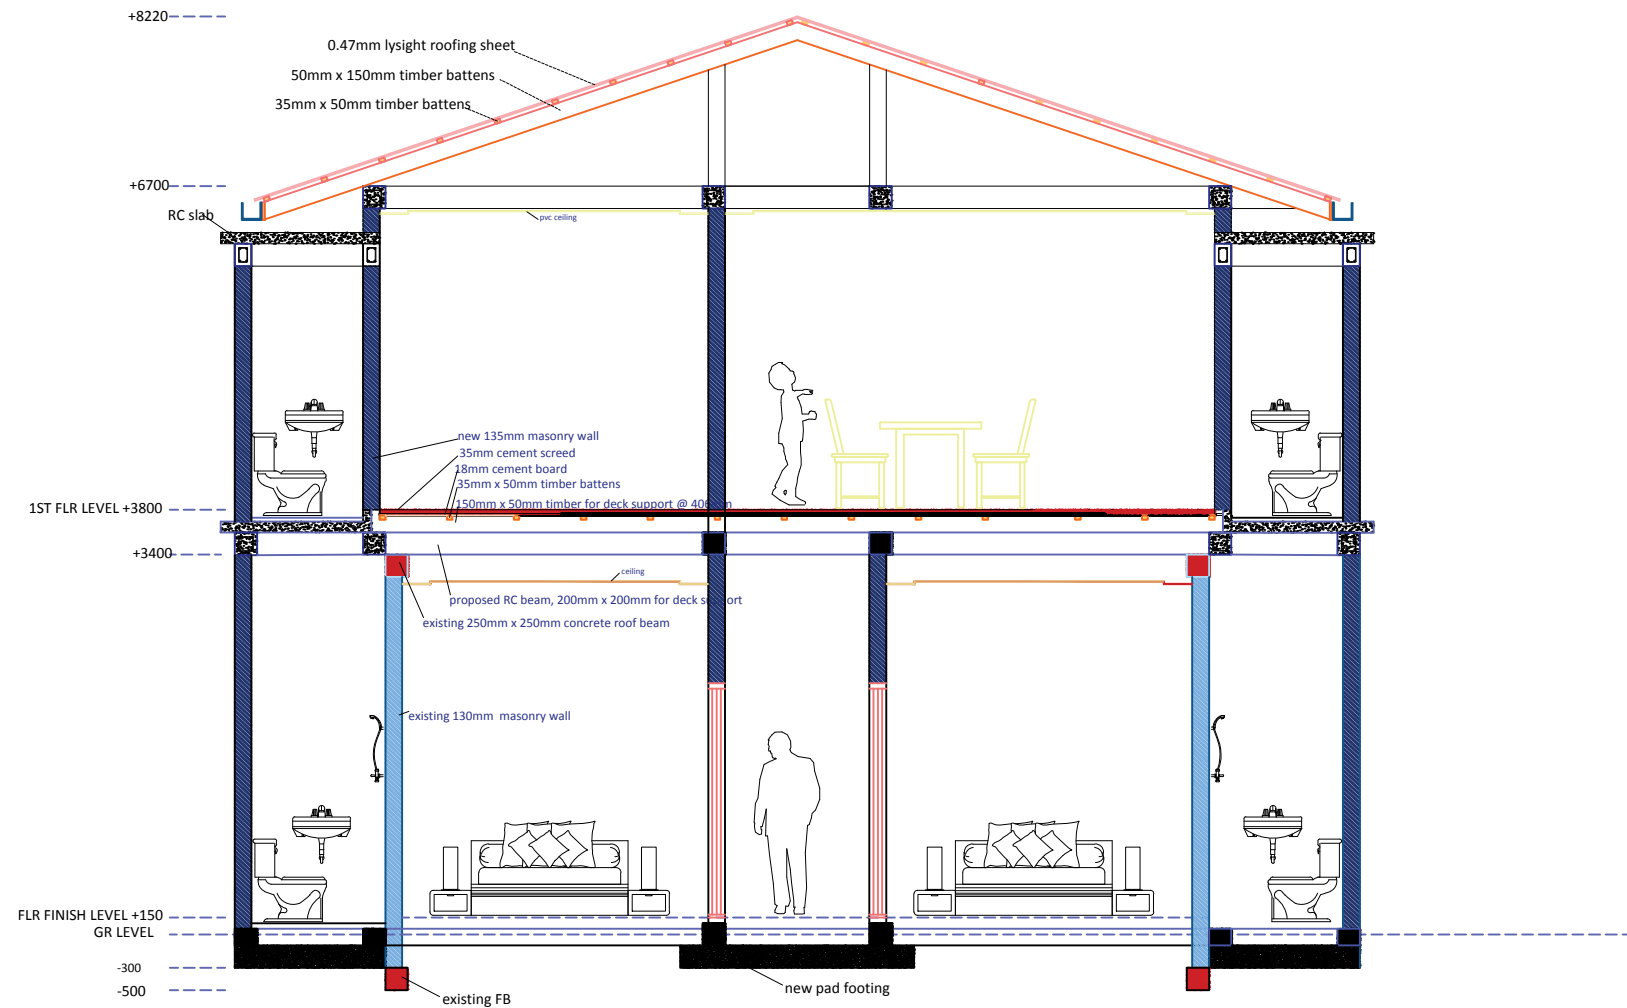


**SECTION X-X**

**PROJECT DETAILS**

PROJECT NAME:	<b>COUNCIL HIYA</b>
CLIENT DETAILS:	<b>INGURAIIDHOO COUNCIL</b>

**DRAWING DETAILS**

<b>SECTION X-X</b>	A11
1:100	
DATE: July 2024	
SHEET NO:	

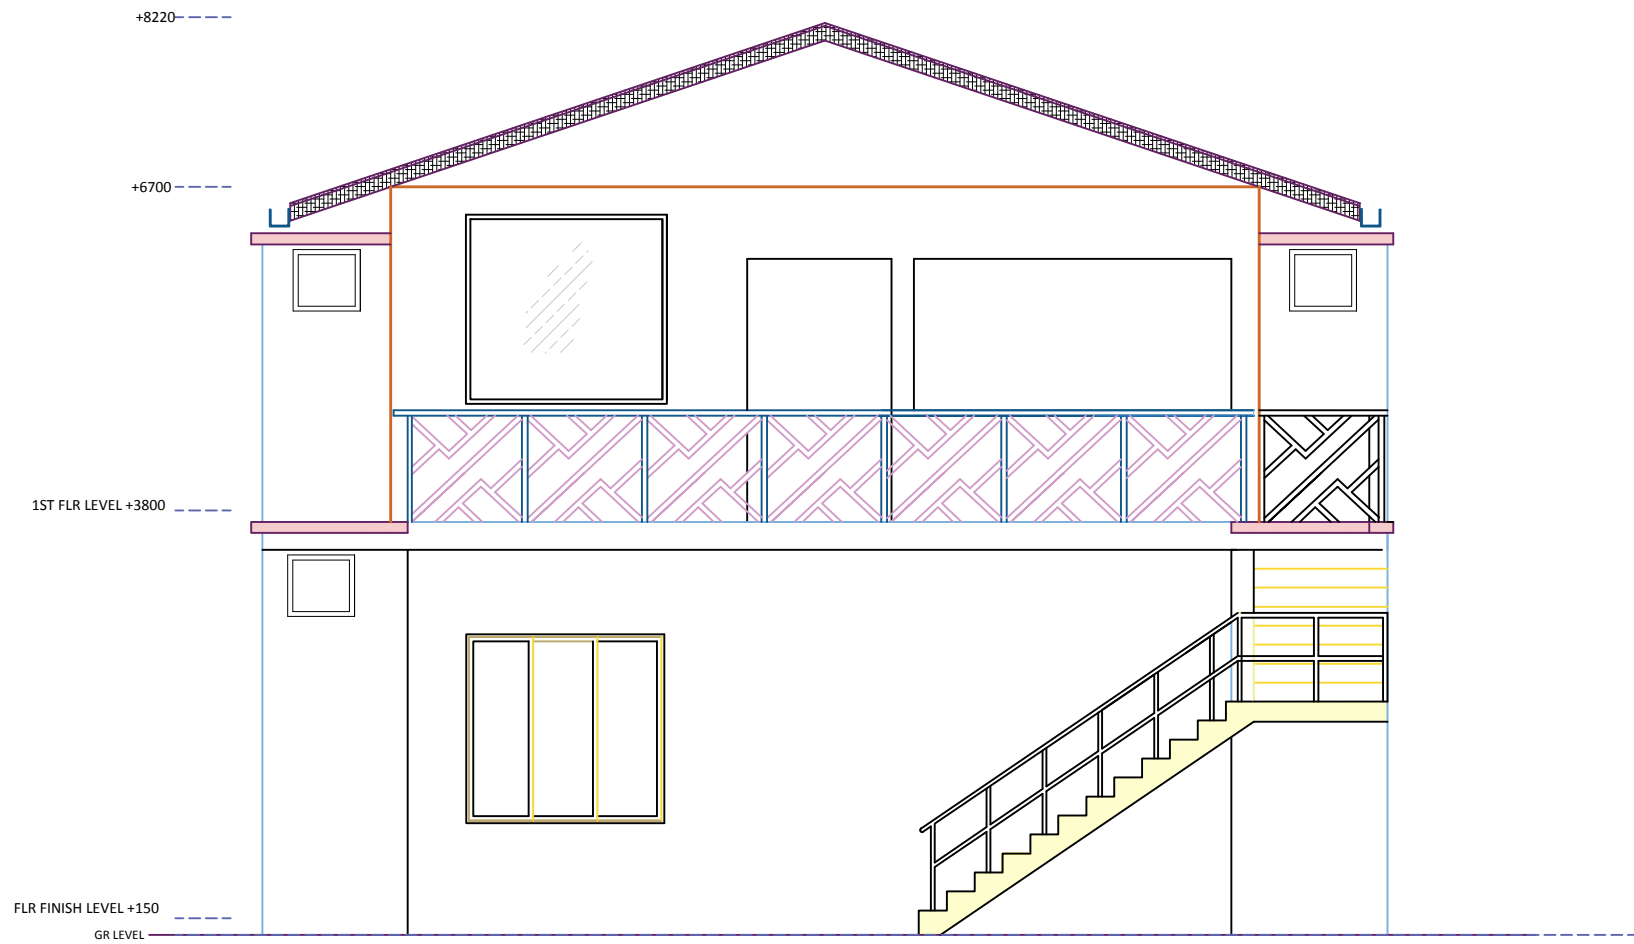


SIDE ELEVATION A

PROJECT DETAILS

PROJECT NAME:	<b>COUNCIL HIYA</b>
CLIENT DETAILS:	<b>INGURAIIDHOO COUNCIL</b>

DRAWING DETAILS

<b>SIDE ELEVATION A</b>	A12
1:100	
DATE: July 2024	
SHEET NO:	

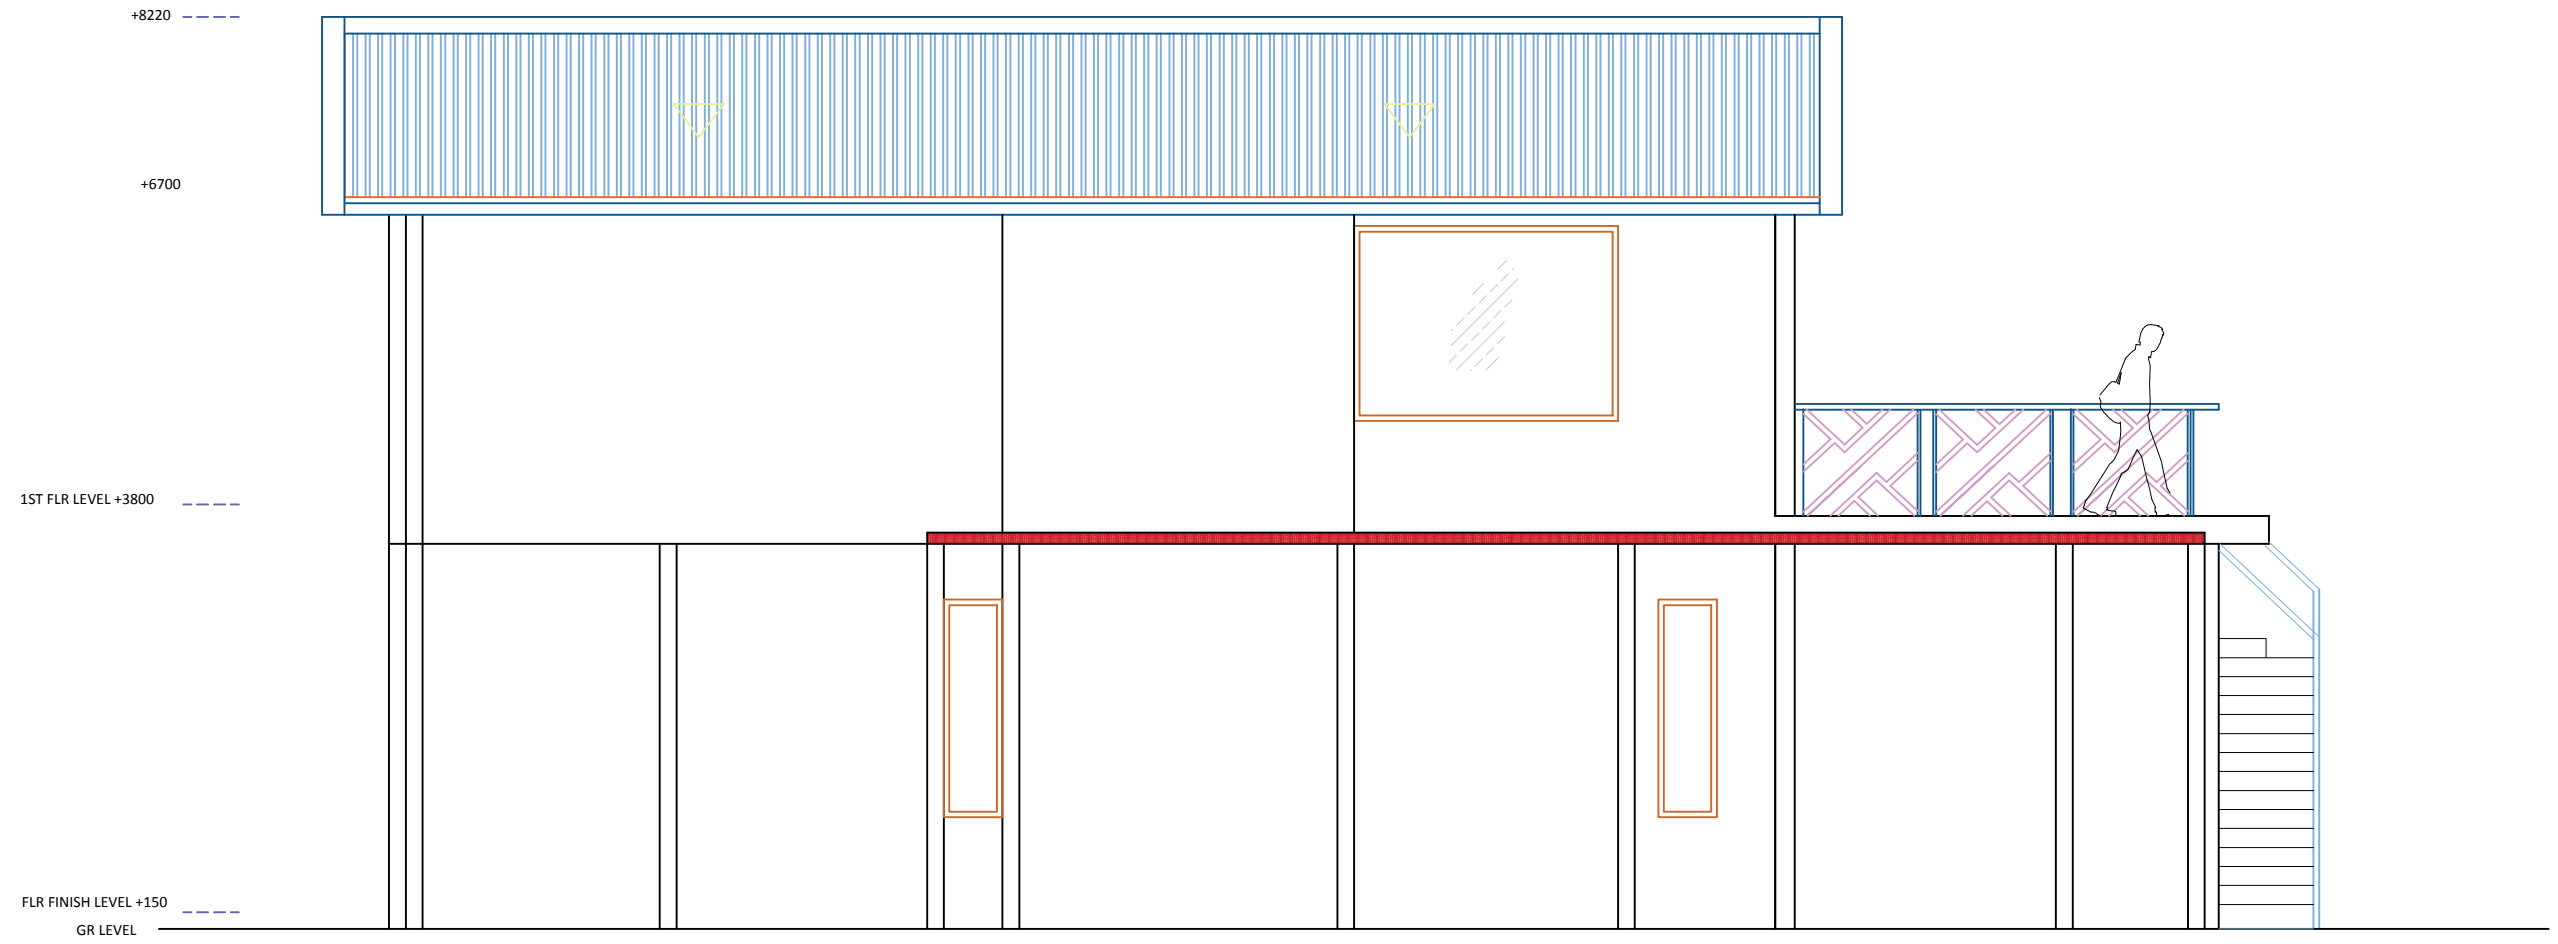


SIDE ELEVATION B

PROJECT DETAILS  
 PROJECT NAME:  
**COUNCIL HIYA**  
 CLIENT DETAILS:  
**INGURAIIDHOO COUNCIL**

DRAWING DETAILS  
**SIDE ELEVATION B**  
 1:100  
 DATE: July 2024  
 SHEET NO:

A13

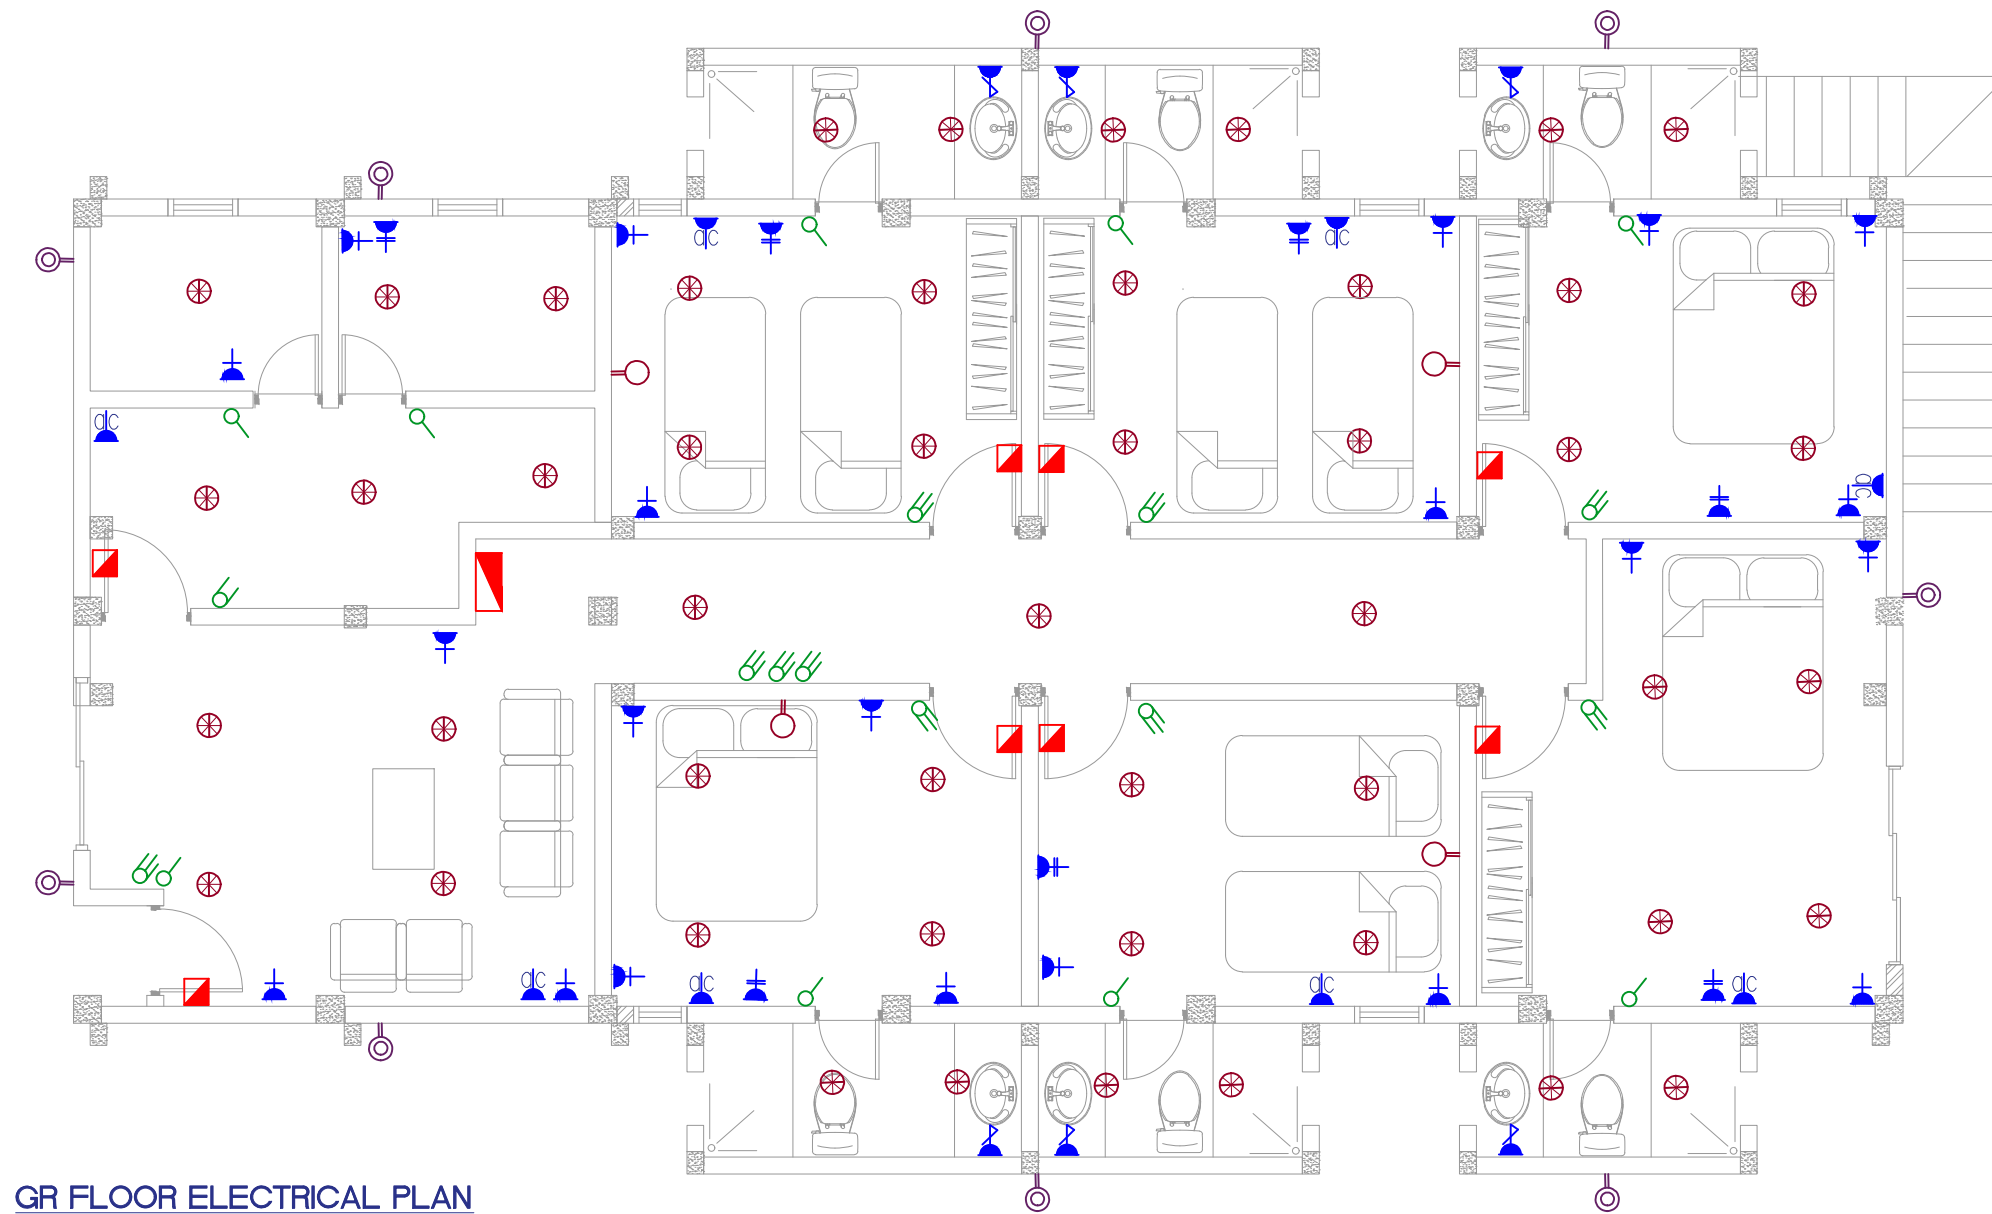

**GR FLOOR ELECTRICAL PLAN**

**LEGENDS**

	1 GANG15A SOCKET OUTLET AT 300MM ABOVE GROUND LEVEL +2600
	WARM WALL MOUNTED LED LIGHT OUTDOOR 24W (+2.5M)(weather proof)
	WARM WALL MOUNT LIGHT 6W (+2.5M)
	WHITE CEILING MOUNT LUMINAIRE 18W
	1 GANG13A SOCKET OUTLET AT 500MM FLOOR FINISH LEVEL
	2 GANG13A SOCKET OUTLET AT 500MM FLOOR FINISH LEVEL
	WARM CEILING MOUNT LUMINAIRE 18W

	1GANG 1 WAY SWITCH AT +1.2M
	2GANG 1 WAY SWITCH AT 1.2 M
	3GANG 1 WAY SWITCH AT 1.2 M
	12 way DISTRIBUTION BOARD AT 2.0M
	MAIN DISTRIBUTION BOARD AT 2.0M
	1 GANG13A SOCKET OUTLET AT 1200MM ABOVE GROUND LEVEL (WEATHER PROOF)
	1 GANG13A SOCKET OUTLET AT 1200mm ABOVE FINISHED FLOOR LEVEL
	EXHAUST 2.7M


	CEILING FAN
--	-------------

**PROJECT DETAILS**

PROJECT NAME: <b>COUNCIL HIYA</b>
CLIENT DETAILS: <b>INGURAIHOO COUNCIL</b>

**DRAWING DETAILS**

<b>GR FLR ELEC. PLAN</b> 1:100	<b>A14</b>
DATE: July 2024	
SHEET NO:	

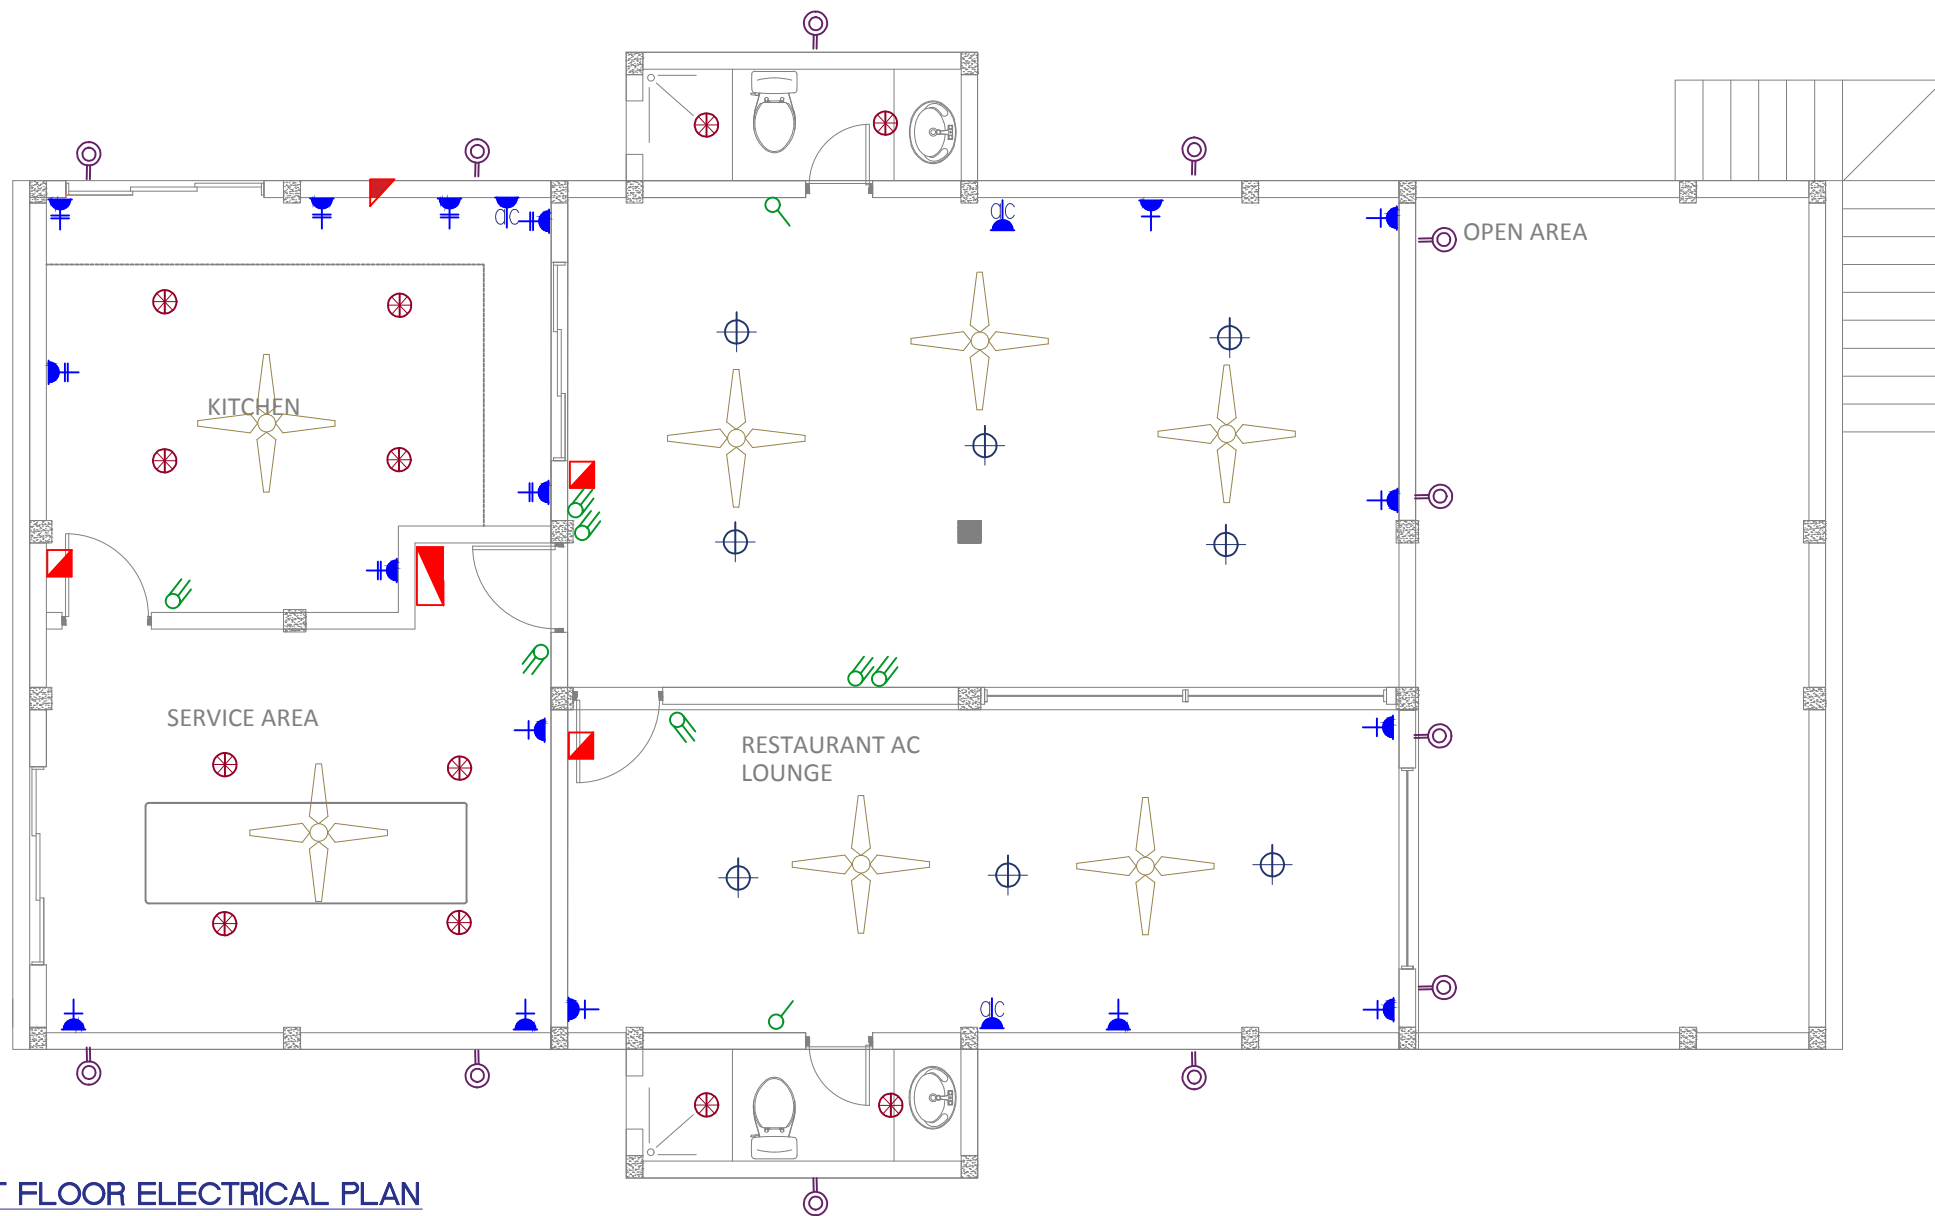

1ST FLOOR ELECTRICAL PLAN

LEGENDS


	1 GANG15A SOCKET OUTLET AT 300MM ABOVE GROUND LEVEL +2600
	WARM WALL MOUNTED LED LIGHT OUTDOOR 24W (+2.5M)(weather proof)
	WARM WALL MOUNT LIGHT 6W (+2.5M )
	WHITE CEILING MOUNT LUMINAIRE 18W
	1 GANG13A SOCKET OUTLET AT 500MM FLOOR FINISH LEVEL
	2 GANG13A SOCKET OUTLET AT 500MM FLOOR FINISH LEVEL
	WARM CEILING MOUNT LUMINAIRE 18W
	1GANG 1 WAY SWITCH AT +1.2M
	2GANG 1 WAY SWITCH AT 1.2 M
	3GANG 1 WAY SWITCH AT 1.2 M
	12 way DISTRIBUTION BOARD AT 2.0M
	MAIN DISTRIBUTION BOARD AT 2.0M
	1 GANG13A SOCKET OUTLET AT 1200MM ABOVE GROUND LEVEL (WEATHER PROOF)
	1 GANG13A SOCKET OUTLET AT 1200mm ABOVE FINISHED FLOOR LEVEL
	EXHAUST 2.7M
	CEILING FAN

PROJECT DETAILS

PROJECT NAME:	COUNCIL HIYA
CLIENT DETAILS:	INGURAIIDHOO COUNCIL

DRAWING DETAILS

1ST FLR ELEC. PLAN	A15
1:100	
DATE: July 2024	
SHEET NO:	

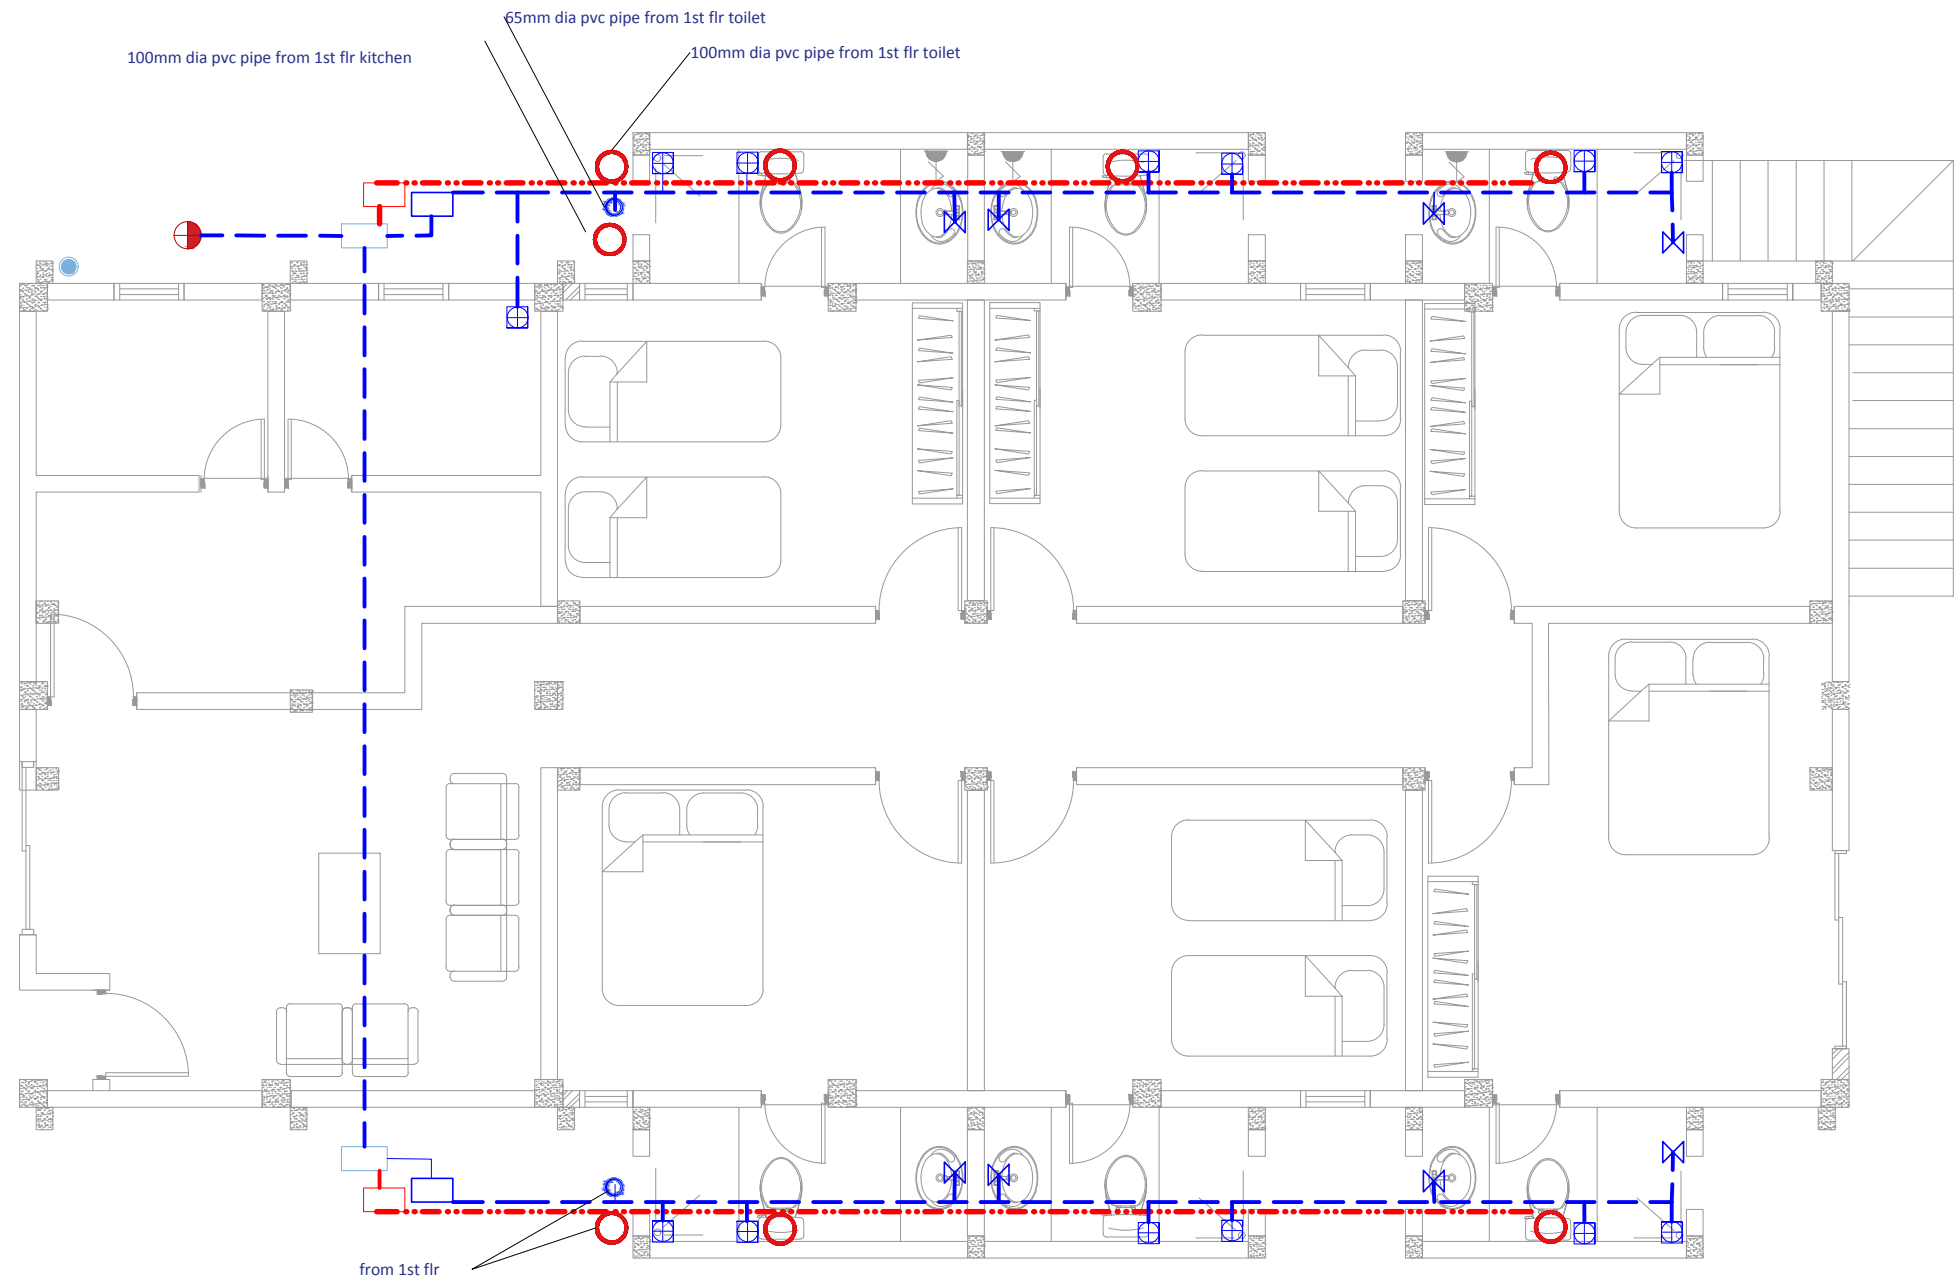

LEGENDS


	100mm dia pvc pipe class-8.5
	65mm dia pvc pipe class-8.5

	wash basin drainage pipe(dia 2") at wall
	floor drain connect to 2-1/2 inch pipe
	100mm dia pvc pipe for rain water collection from roof
	FENAKA drainage collection pit
	blackwater collection chamber
	greywater collection chamber
	inspection chamber


GR FLOOR PLUMBING

PROJECT DETAILS	DRAWING DETAILS
PROJECT NAME: <b>COUNCIL HIYA</b>	<b>GR FLOOR PLUMBING</b> 1:100
CLIENT DETAILS: <b>INGURAIIDHOO COUNCIL</b>	DATE: July 2024
	SHEET NO: <b>A16</b>




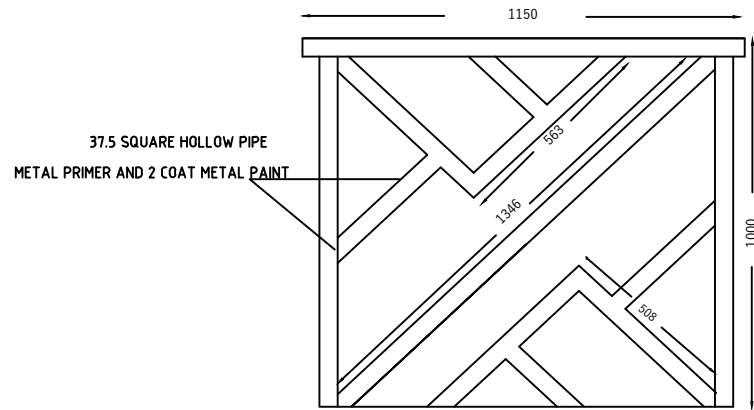

**BALCONY RAILING DETAIL**

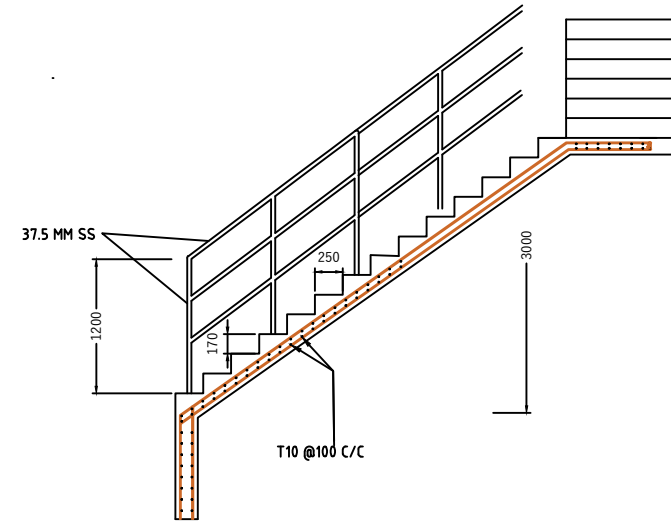

**STAIR DETAIL**

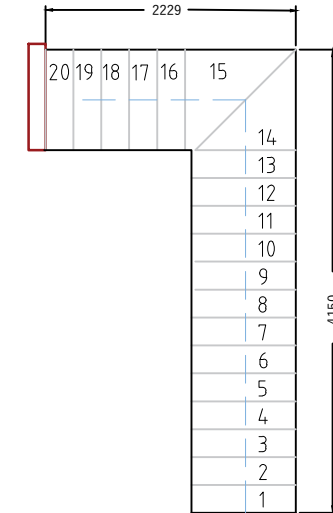

DOOR LABEL	D1	D2	SD1	SD2	V1	FW1	W1
DESCRIPTION	SWING DOOR TIMBER FRAMED IRONMONGERY = S.S	SWING DOOR FRAME=ALUM+CLADING SHEET IRONMONGERY = S.S	SLIDING WINDOW FRAME=A+PANEL=G IRONMONGERY = S.S	WINDOW FRAME=A+PANEL=G IRONMONGERY = S.S	VENT FRAME=A+PANEL=G IRONMONGERY = S.S	FIXED GLASS WINDOW FRAME=A+PANEL=G IRONMONGERY = S.S	SWING WINDOW FRAME=A+PANEL=G IRONMONGERY = S.S
QTY	11	10	4	1	8	2	5

**DOOR WINDOW SCHEDULE**

**PROJECT DETAILS**

PROJECT NAME: <b>COUNCIL HIYA</b>
CLIENT DETAILS: <b>INGURAI DHOO COUNCIL</b>

**DRAWING DETAILS**

<b>DOOR WINDOW SCHEDULE &amp; STAIR DETAIL</b> 1:100
DATE: July 2024
SHEET NO: <b>A17</b>