



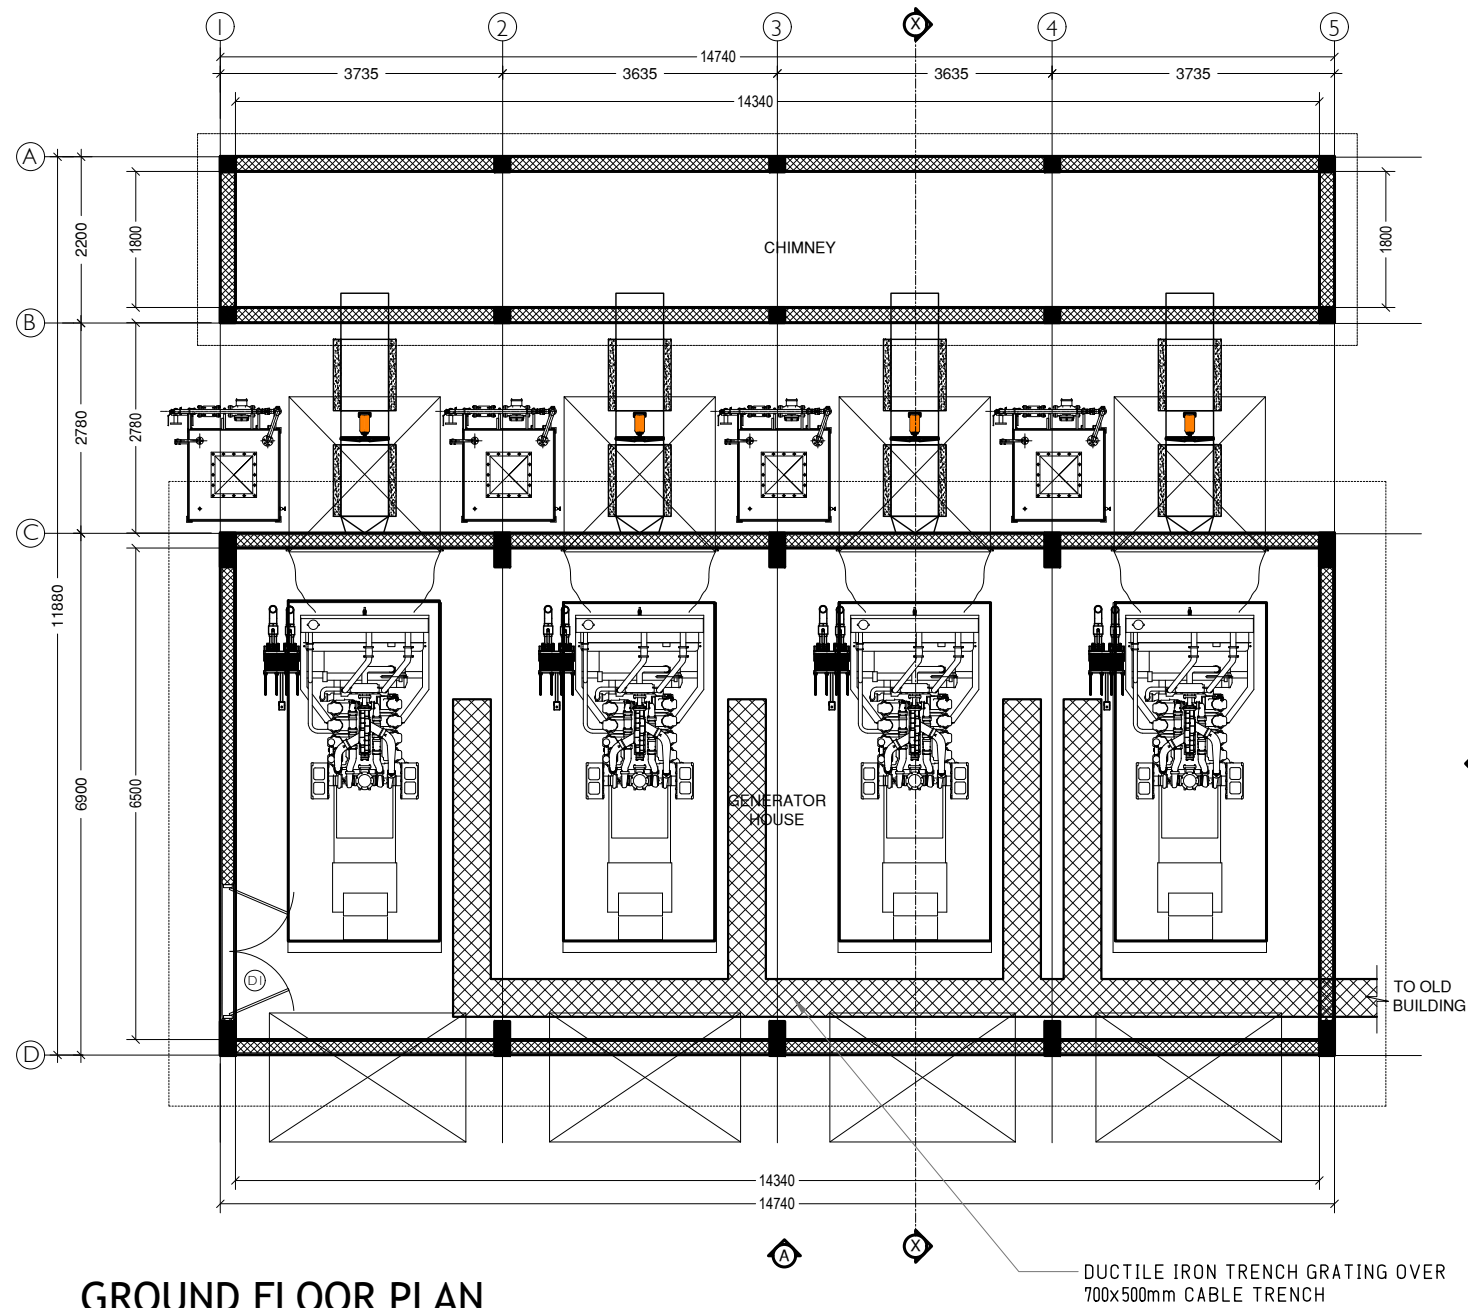

GROUND FLOOR PLAN
SCALE 1:100

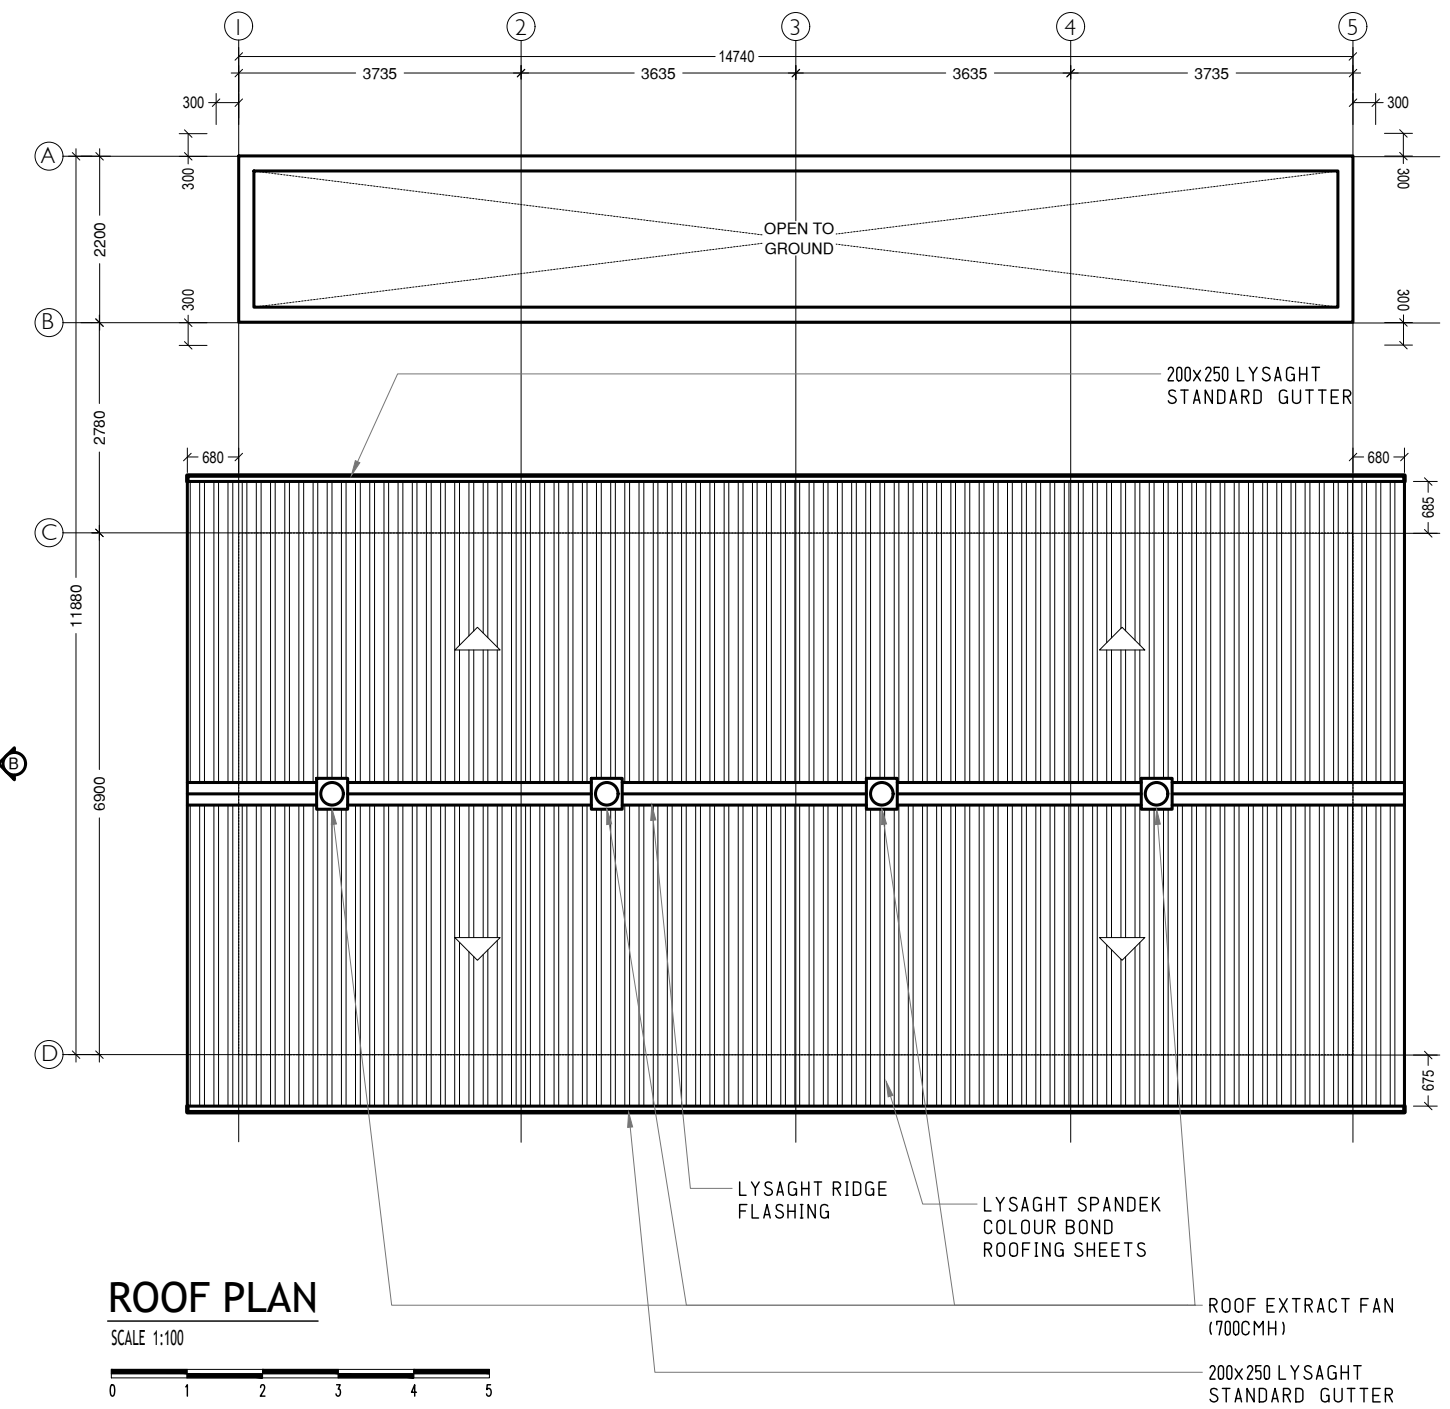

ROOF PLAN
SCALE 1:100

PROJECT : R. VANDHOO PROJECT: SOLID WASTE MANAGEMENT FACILITY CLIENT : MINISTRY OF ENVIRONMENT AND ENERGY CONSULTANT : HUSSAIN SHAHEED	DRAWN BY : ARIF CHECKED BY : HUSSAIN SHAHEED TITLE : AS GIVEN SCALE : AS GIVEN DATE: 19.01.2019 PG NO.	DWG NO: VAN-TD-08A-G-1.02-R0 REV. NO: R0-190119/01 REV. NOTES - - - - -	APPROVED BY: APPROVED DATE: