


# ELECTRICAL LAYOUT

## AT GRH

SCALE: 1 : 100

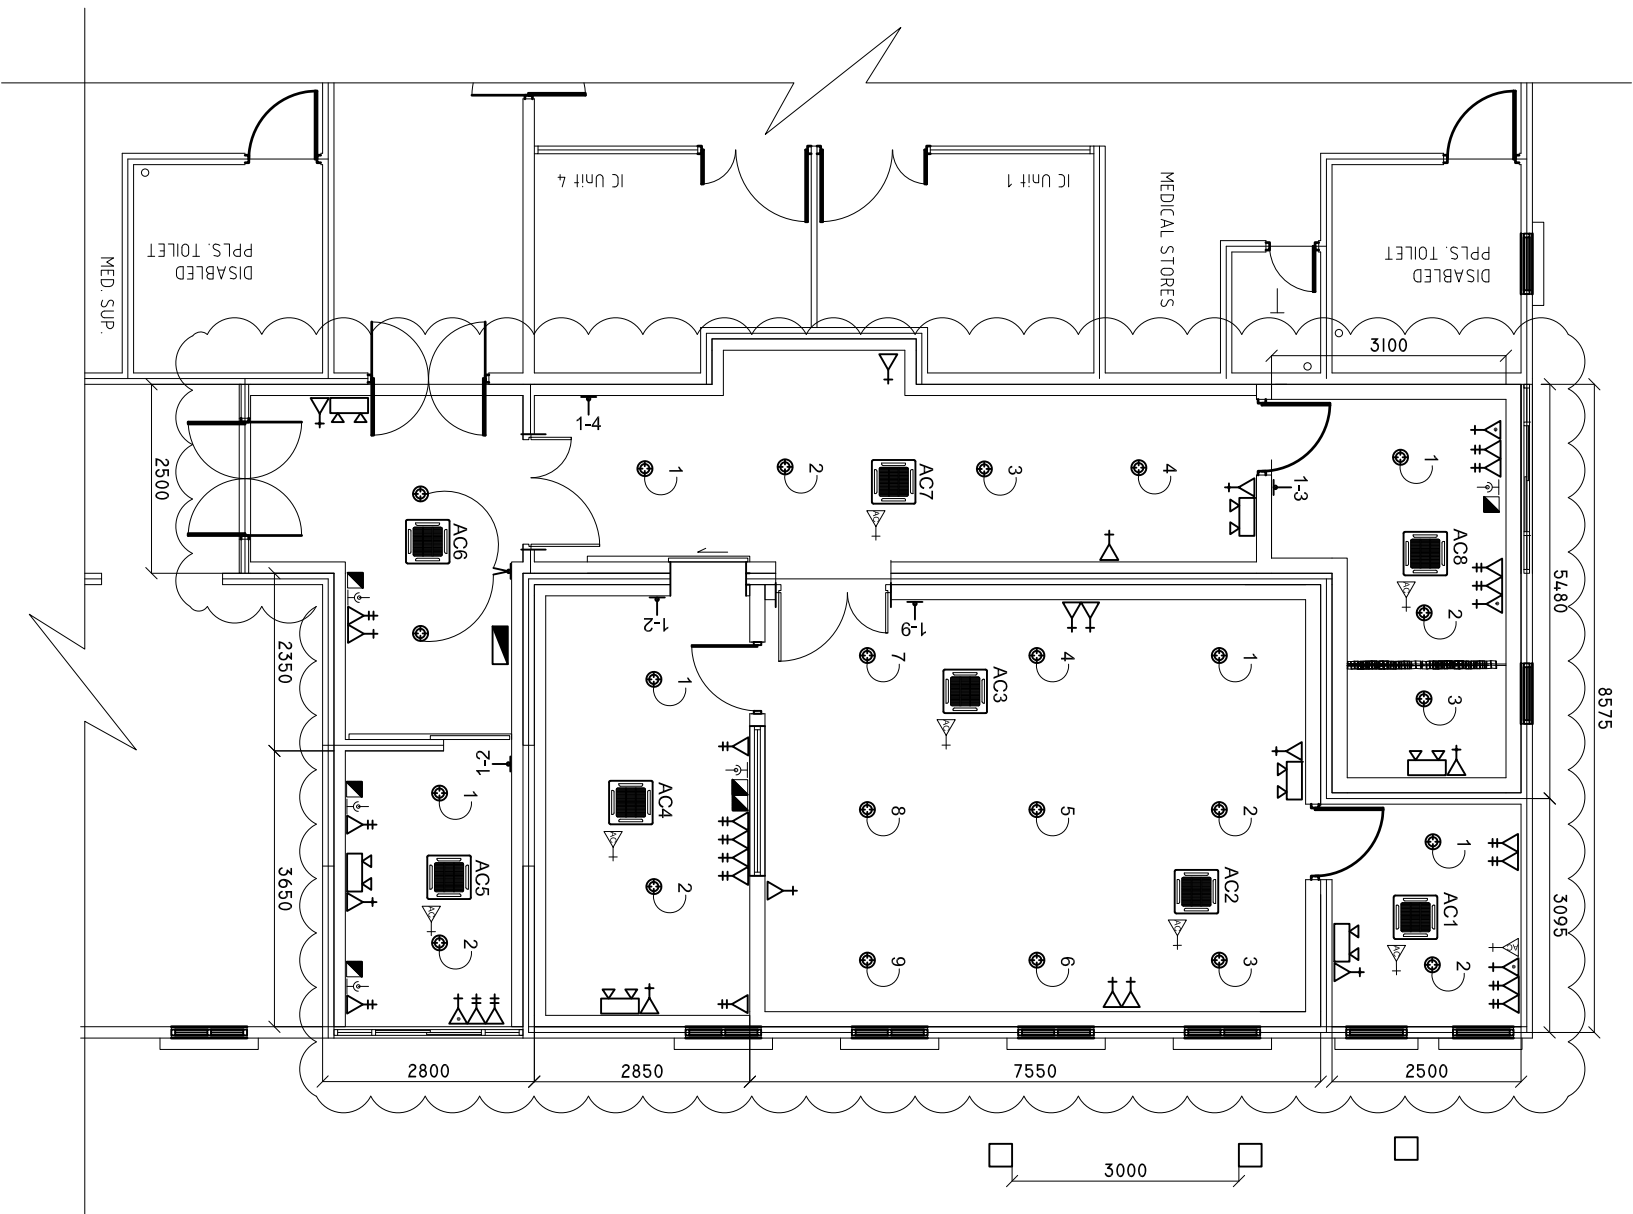

### LEGEND

SYMBOL	DESCRIPTION
	LED BULB WITH 150MM DOWN LIGHT
	1 x 13 AMP SOCKET OUTLET (1600MM ABOVE FFL)
	2 x 13 AMP SOCKET OUTLET (600MM ABOVE FFL)
	1 x 15 AMP SOCKET OUTLET (600MM ABOVE FFL)
	1 x 15 AMP AC SOCKET OUTLET ( 300MM BL.W, CEILING)
	TWO GANG SWITCH
	ONE WAY SWITCH
	EMERGENCY LIGHT
	DISTRIBUTION BOARD ( WALL EMBEDDED )
	TELEPHONE SOCKET
	NETWORK SOCKET
	1 x 13 AMP SOCKET OUTLET (200MM BELOW CEILING)
	AC OUTDOOR UNIT
	AC INDOOR UNIT, CEILING CASSETTE TYPE
	EARTH PIT