


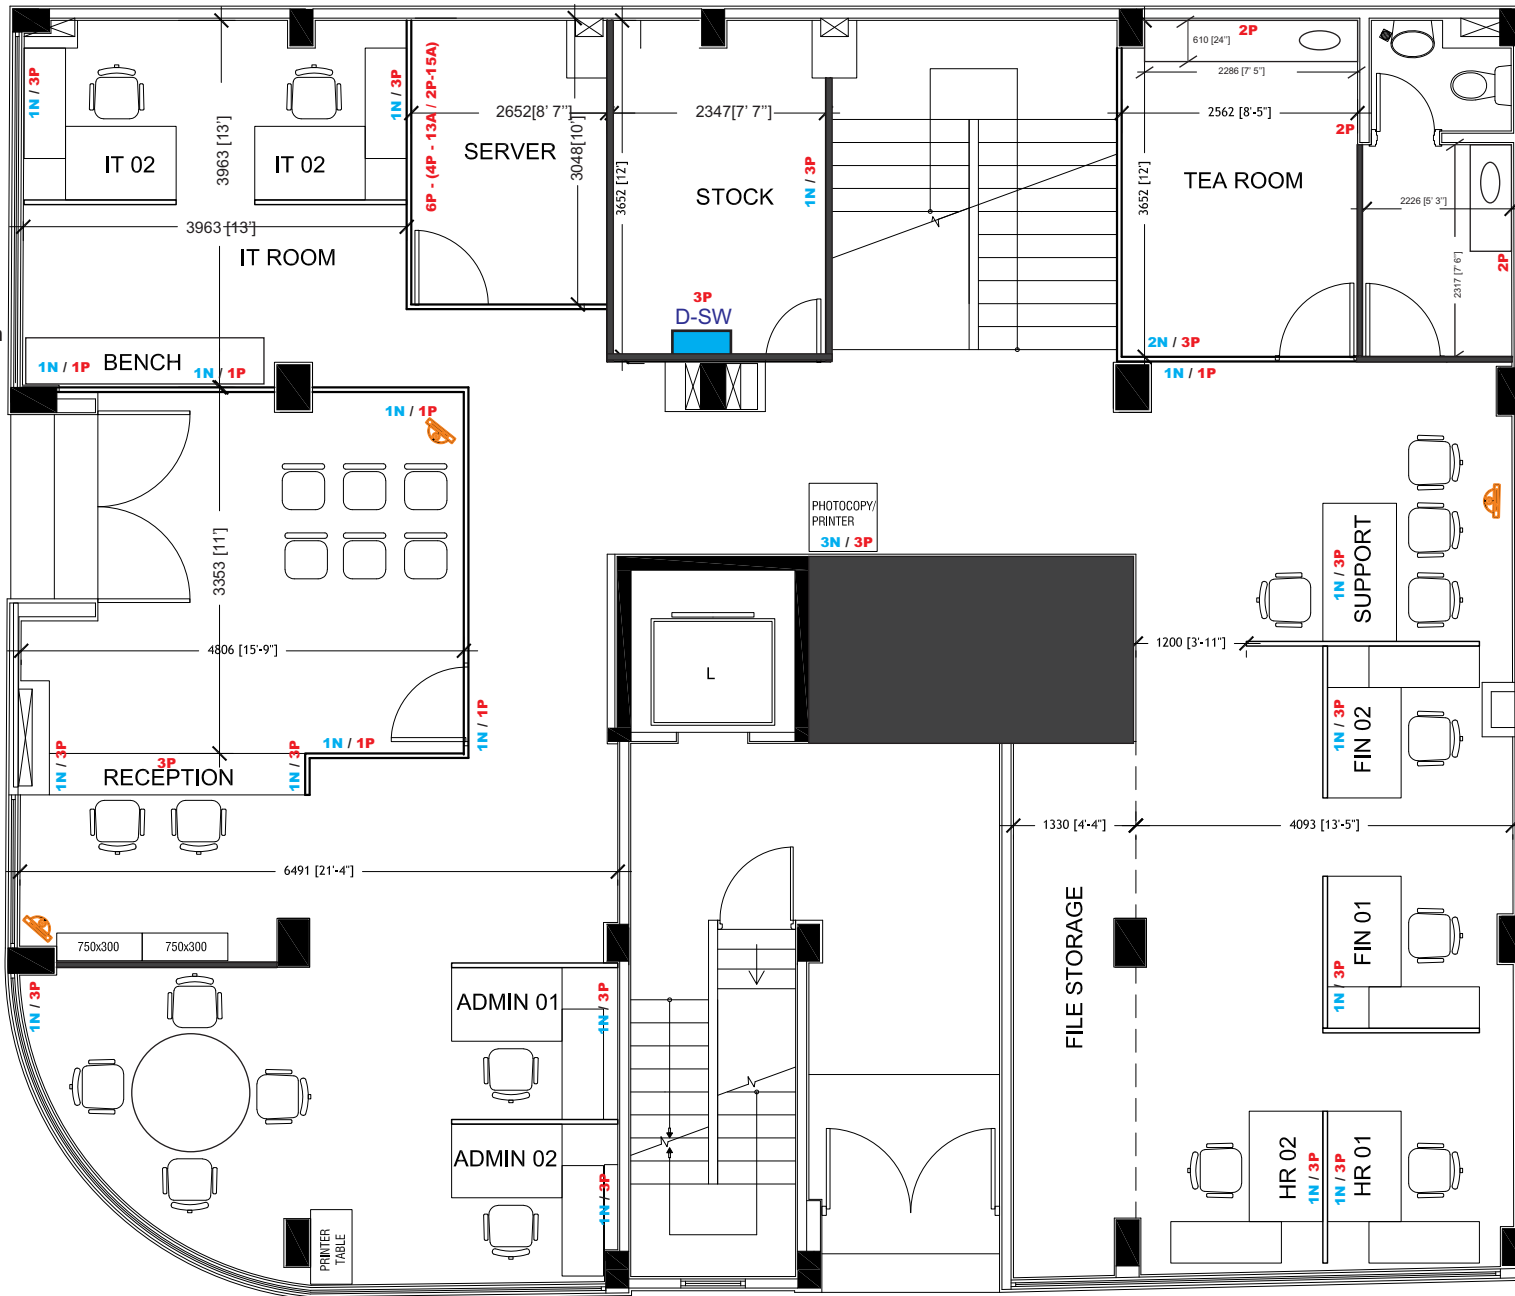



- N - NETWORK POINT**
- P - POWER POINT**
- D-SW - DISTRIBUTION SWITCH**
- 5U RACK**
-  CCTV Indoor
-  Wooden Partition
-  Aluminum Partition








SHAHEEDHU KUDA ADHAMUGE KUDA THUTHU HIGUN (20')

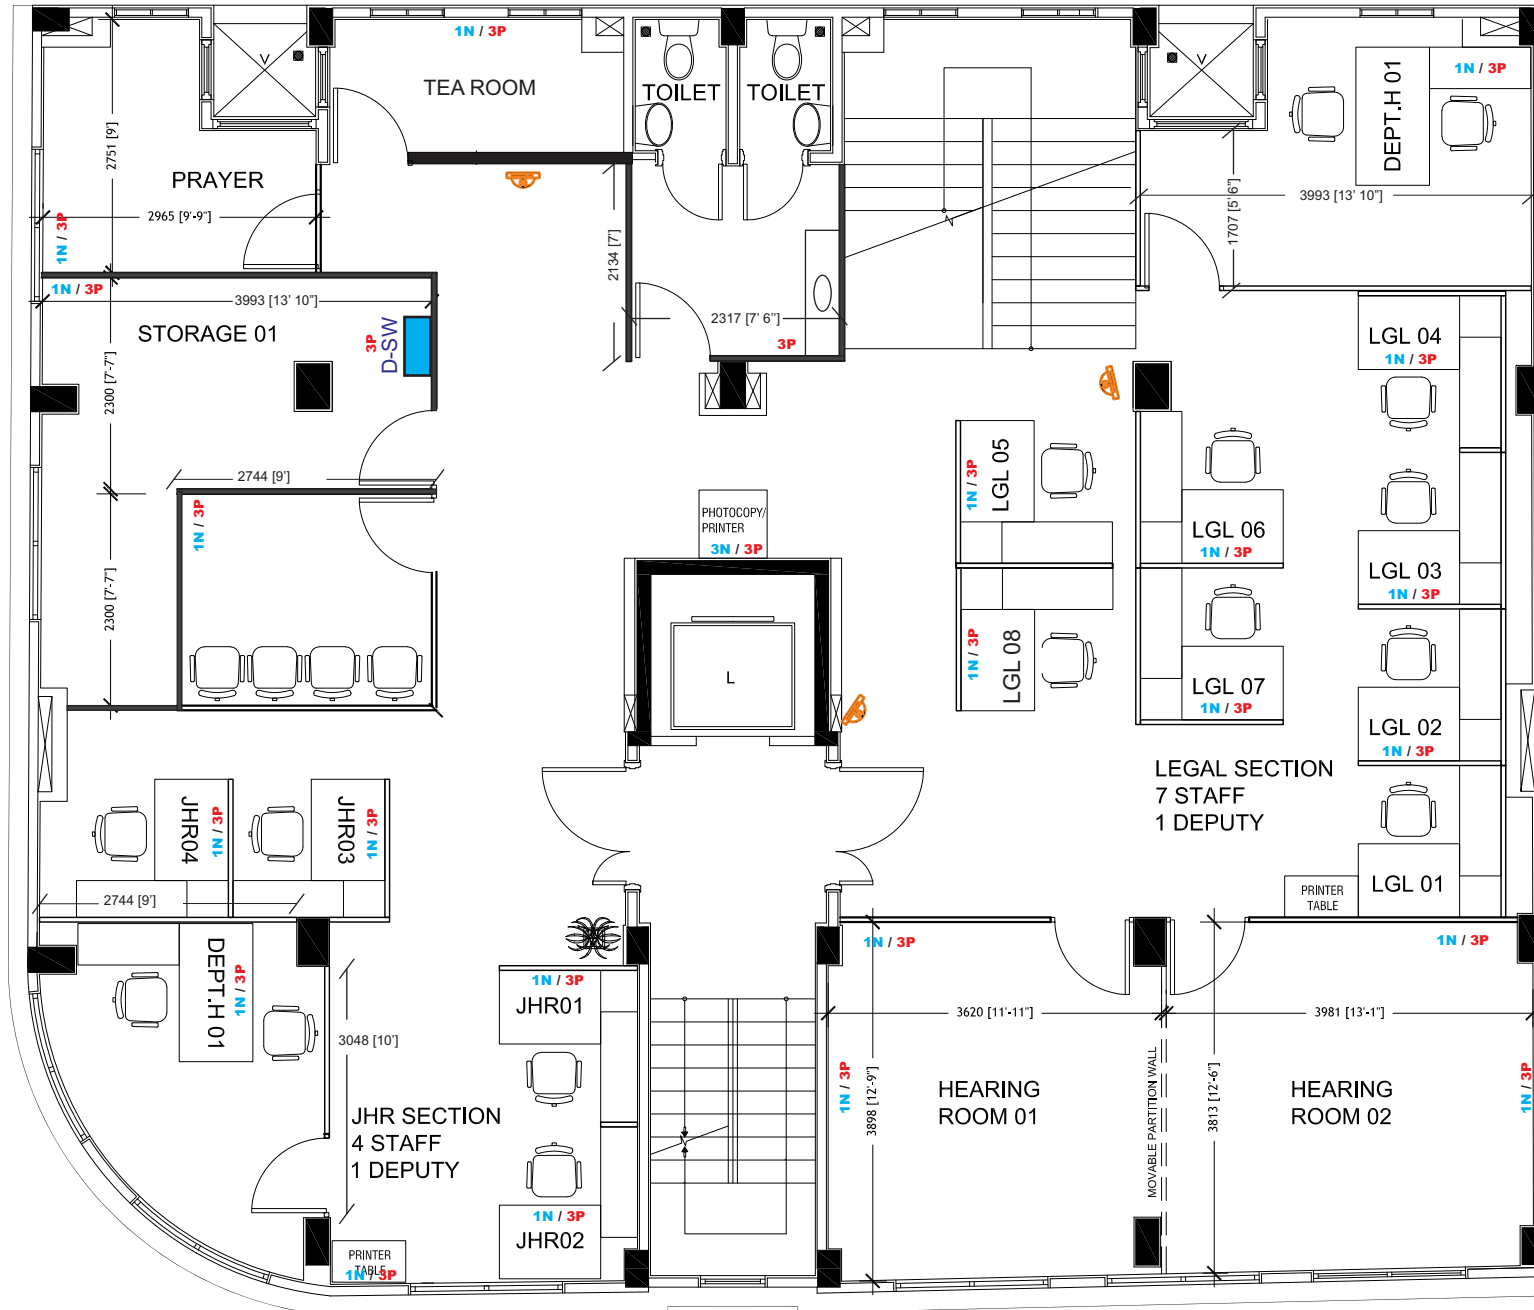PROPOSED SPACE LAYOUT FOR JSC AT H. SAKEENA MANZIL - 2ND DRAFT
GROUND FLOOR PLAN
 SCALE 1:100

- N - NETWORK POINT**
- P - POWER POINT**
- D-SW - DISTRIBUTION SWITCH**
- 5U RACK**
- CCTV Indoor**
- Wooden Partition**
- Aluminum Partition**



- N - NETWORK POINT**
- P - POWER POINT**
- D-SW - DISTRIBUTION SWITCH**
-  **5U RACK**
-  **CCTV Indoor**
-  **Wooden Partition**
-  **Aluminum Partition**

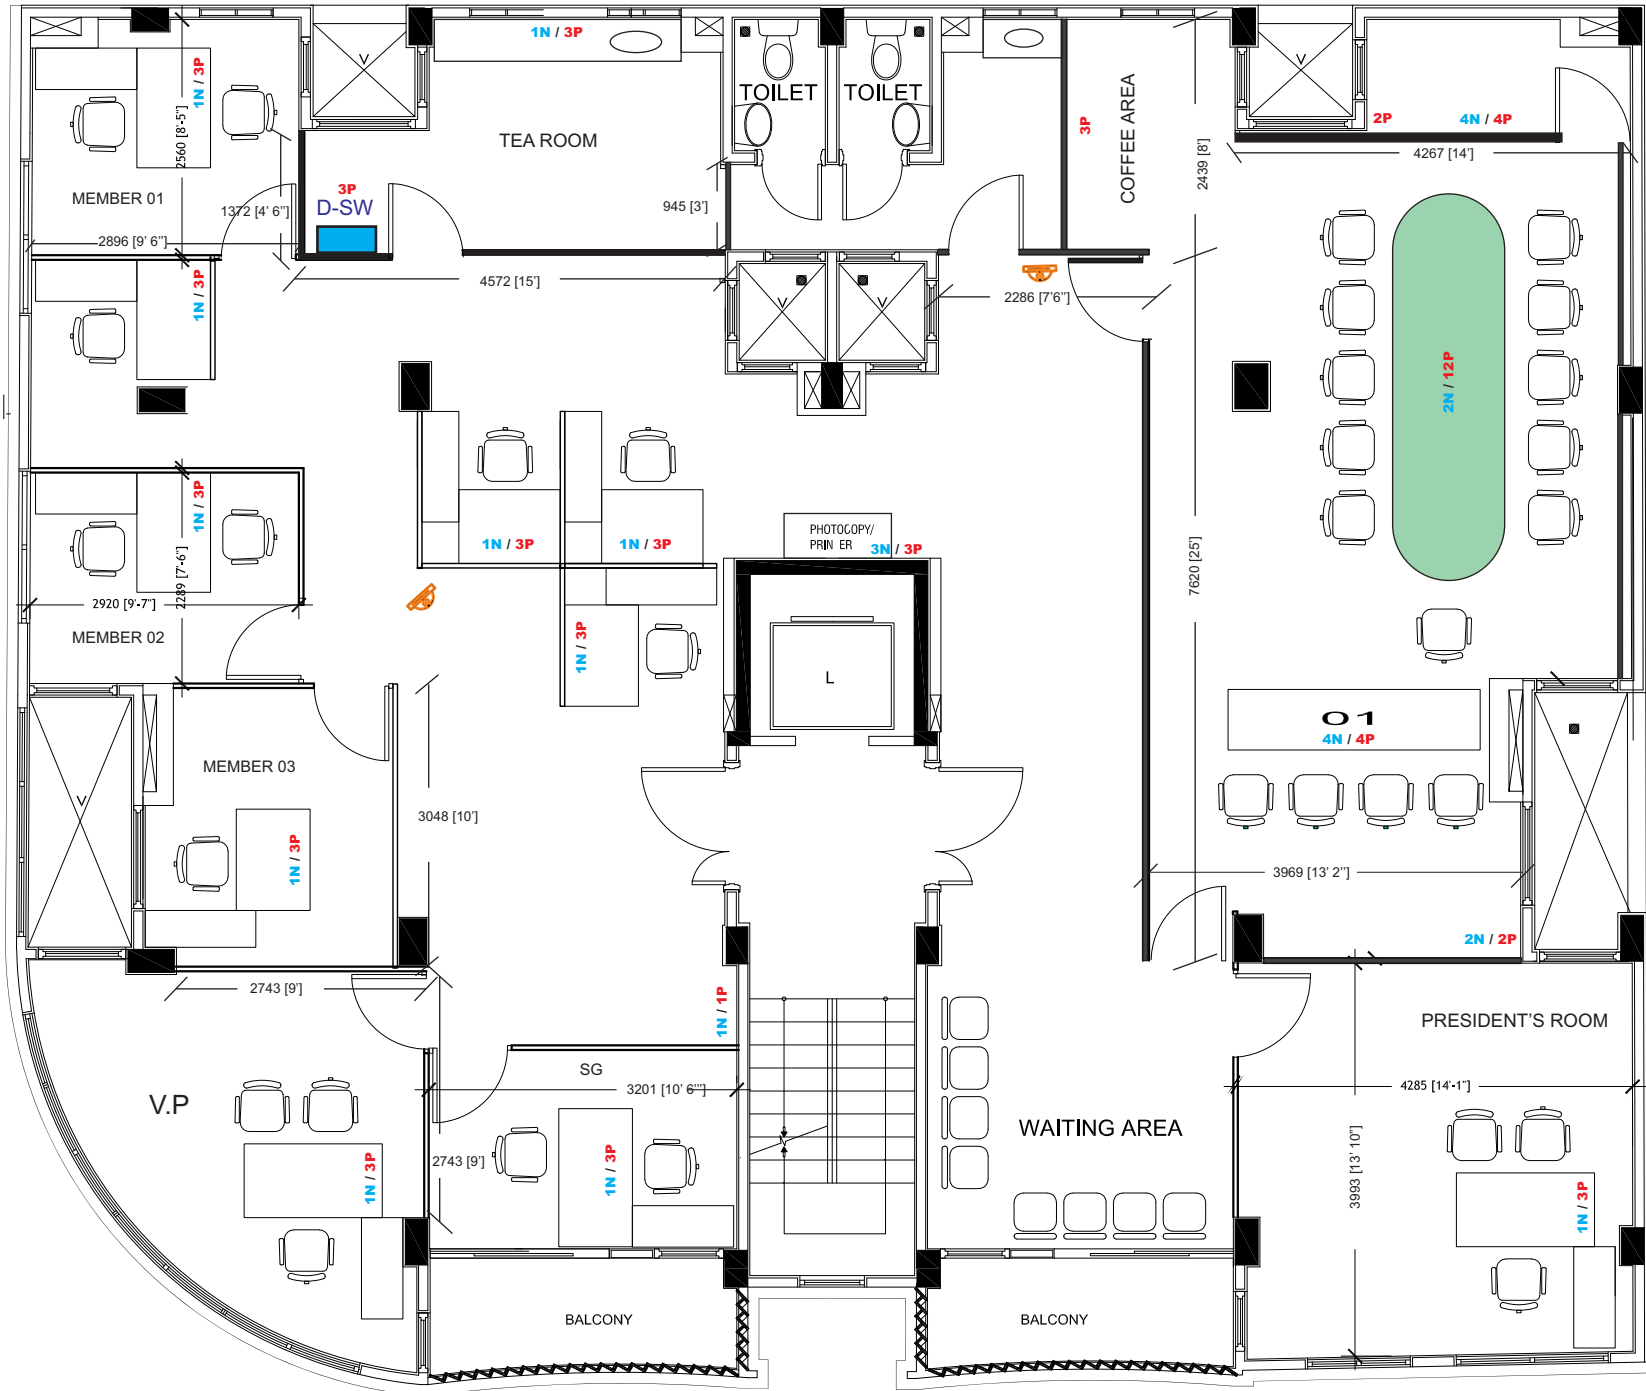

PROPOSED SPACE LAYOUT FOR JSC AT H. SAKEENA MANZIL - 2ND DRAFT
SECOND FLOOR PLAN
 SCALE 1:100