

PROPOSED 2 STOREY CLASSROOM & TEA ROOM EXTENSION

MNU FHS BUILDING

13 JUNE 2026

PROJECT DATA

PROPOSED 2 STOREY CLASSROOM & TEA ROOM EXTENSION

CLIENT: MNU

LOCATION: MNU FHS BUILDING

COVER SHEET & GENERAL NOTES

0000	COVER PAGE	NTS
G000	DRAWING INDEX, NOTES	NTS

ARCHITECTURAL & MEP DRAWINGS (TEA ROOM)

A100	2ND FLOOR TERRACE EXISTING LAYOUT	1:50
A101	PROPOSED AREAS FOR EXTENSION	1:50
A102	EXISTING AND PROPOSED LAYOUT TEA ROOM	1:50
A103	TEA ROOM CEILING LAYOUT	1:50
A104	DOOR WINDOW SCHEDULE 01	1:50
A105	DOOR WINDOW SCHEDULE 02	1:50
M100	TEA ROOM ELECTRICAL AND POWER LAYOUT	1:50
M101	TEA ROOM AC LAYOUT	1:50
M101	TEA ROOM WATER SUPPLY & DRAINAGE LAYOUT	1:50

ARCHITECTURAL & MEP DRAWINGS (CLASSROOM BUILDING)

A200	CLASSROOM LAYOUT – LEVEL 01	1:50
A201	CLASSROOM LAYOUT – LEVEL 02	1:50
A202	ROOF PLAN	1:50
A203	ELEVATION 01	1:50
A204	SECTION – X	1:50
A205	SECTION – Y	1:50
A206	DOOR/WINDOW SCHEDULE–CLASSROOM BUILDING	1:50
A300	ARCHITECTURAL DETAILS 01	1:20
A301	ARCHITECTURAL DETAILS 02	1:20
A302	STAIR DETAILS	1:20/50
A400	FLOOR FINISH DETAILS	1:100
A401	REFLECTED CEILING LAYOUT	1:100
M100	CLASSROOM 01 & 02 ELECTRICAL LAYOUT	1:100
M101	CLASSROOM 01 & 02 POWER LAYOUT	1:100
M101	CLASSROOM 01 & 02 AC LAYOUT	1:100

GENERAL NOTES


- ALL DIMENSIONS SHALL BE VERIFIED ON SITE PRIOR TO COMMENCEMENT OF WORK.
- CONTRACTOR SHALL REPORT ANY DISCREPANCIES TO THE CONSULTANT BEFORE PROCEEDING WITH THE WORKS.
- DO NOT SCALE DRAWINGS. USE WRITTEN DIMENSIONS ONLY.
- ALL MATERIALS SHALL BE INSTALLED IN ACCORDANCE WITH THE MANUFACTURER'S RECOMMENDATIONS.
- SHERA BOARD CLADDING SHALL BE INSTALLED ON AN APPROVED SUPPORT FRAMING SYSTEM.
- PROVIDE ALL NECESSARY FLASHINGS, SEALANTS, WATERPROOFING MEMBRANES, FIXINGS, AND ACCESSORIES REQUIRED FOR A COMPLETE WEATHER-TIGHT INSTALLATION.
- ALL EXTERNAL JOINTS SHALL BE SEALED AND FINISHED TO PREVENT WATER INGRESS.
- WATERPROOFING MEMBRANES SHALL BE CONTINUOUS AND LAPPED IN A SHINGLE FASHION TO ENSURE POSITIVE DRAINAGE.
- PROVIDE APRON FLASHINGS, COUNTER FLASHINGS, AND TERMINATION DETAILS AT ALL ROOF-TO-WALL INTERFACES.
- ALL METAL COMPONENTS SHALL BE CORROSION-RESISTANT AND SUITABLE FOR MARINE ENVIRONMENTS.
- CONTRACTOR SHALL PROTECT EXISTING BUILDING ELEMENTS FROM DAMAGE DURING CONSTRUCTION.
- SHOP DRAWINGS SHALL BE SUBMITTED FOR REVIEW PRIOR TO FABRICATION AND INSTALLATION.
- FINAL PANEL LAYOUT AND JOINT LOCATIONS SHALL BE COORDINATED WITH SITE CONDITIONS.

PROJECT: PROPOSED 2 STOREY CLASSROOM EXTENSION & TEA ROOM LOCATION: MALE, MALDIVES CLIENT: MNU	DISCIPLINE: ARCHITECTURAL DRAWING TITLE: DRAWING INDEX, GENERAL NOTES	PAPER SIZE SCALE DATE	A3 NTS 13 JUNE 2026
		SHEET NO: G000	

ARCHITECTURAL DRAWINGS

TEA ROOM

13 JUNE 2026

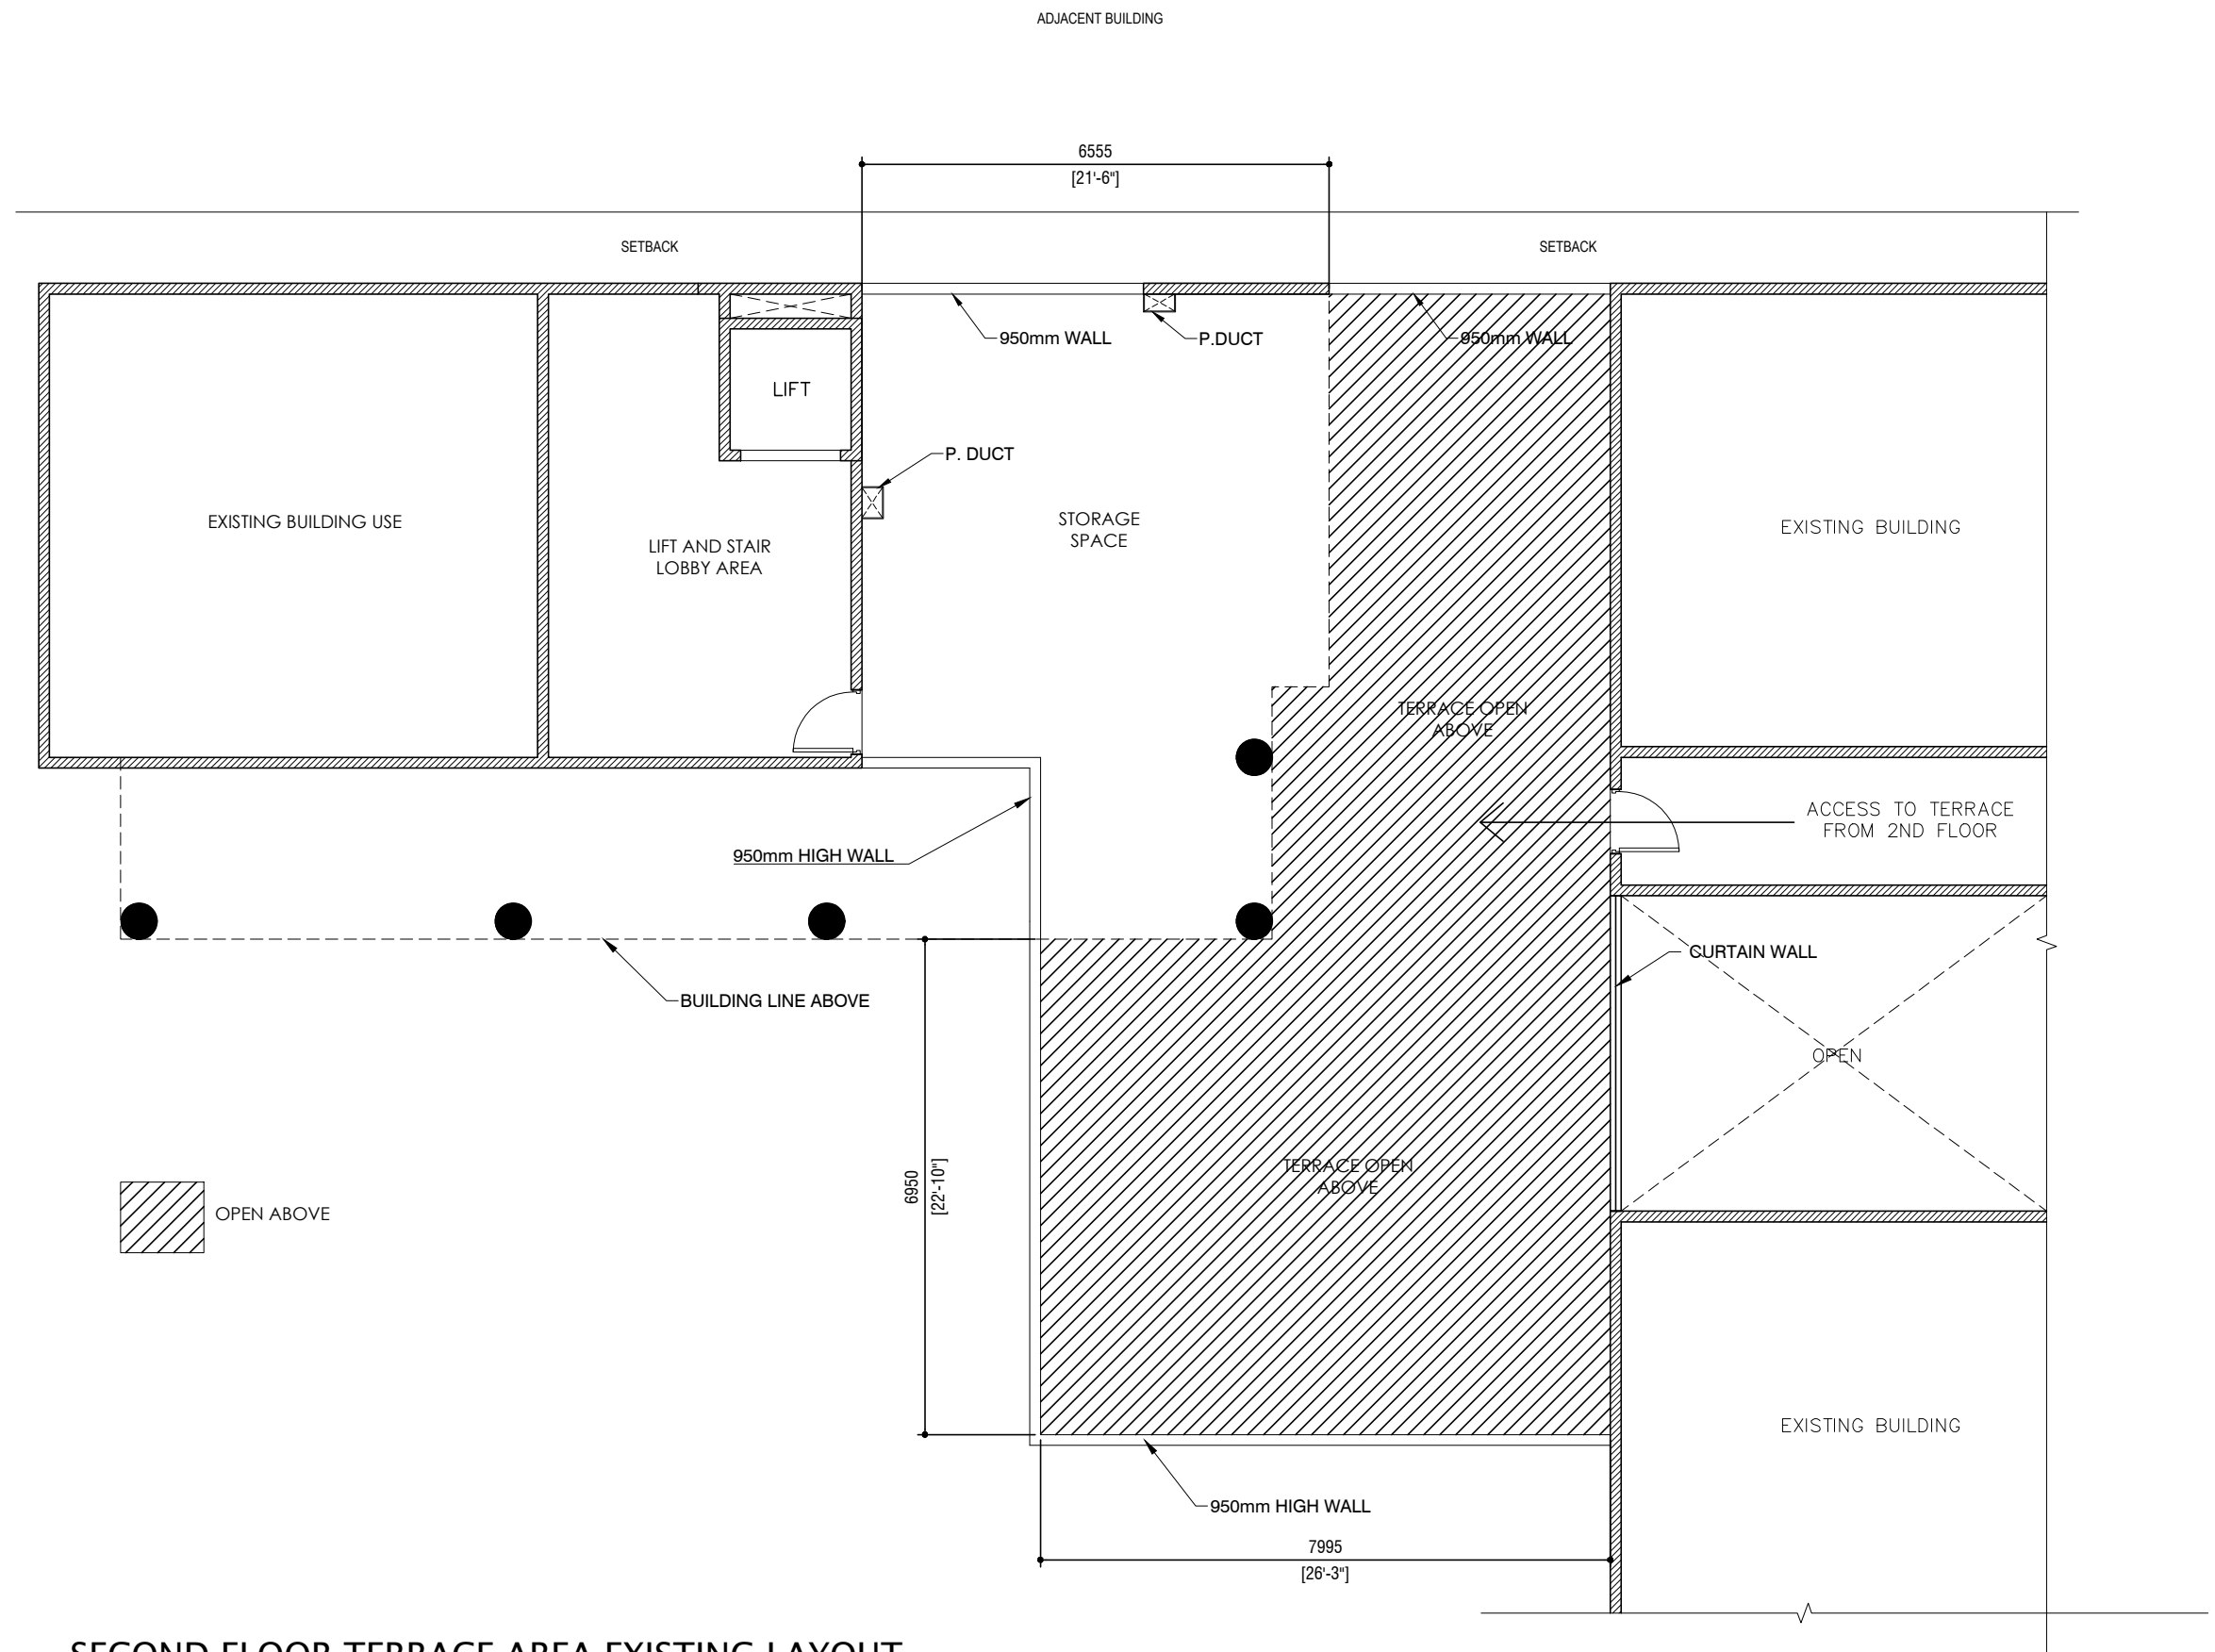


SECOND FLOOR TERRACE AREA EXISTING LAYOUT

SCALE 1:100



PROJECT: PROPOSED 2 STOREY CLASSROOM EXTENSION & TEA ROOM LOCATION: MALE, MALDIVES CLIENT: MNU	DISCIPLINE: ARCHITECTURAL DRAWING TITLE: SECOND FLOOR TERRACE AREA EXISTING LAYOUT	PAPER SIZE SCALE DATE	A3 1:100 13 JUNE 2026
		SHEET NO: A100	

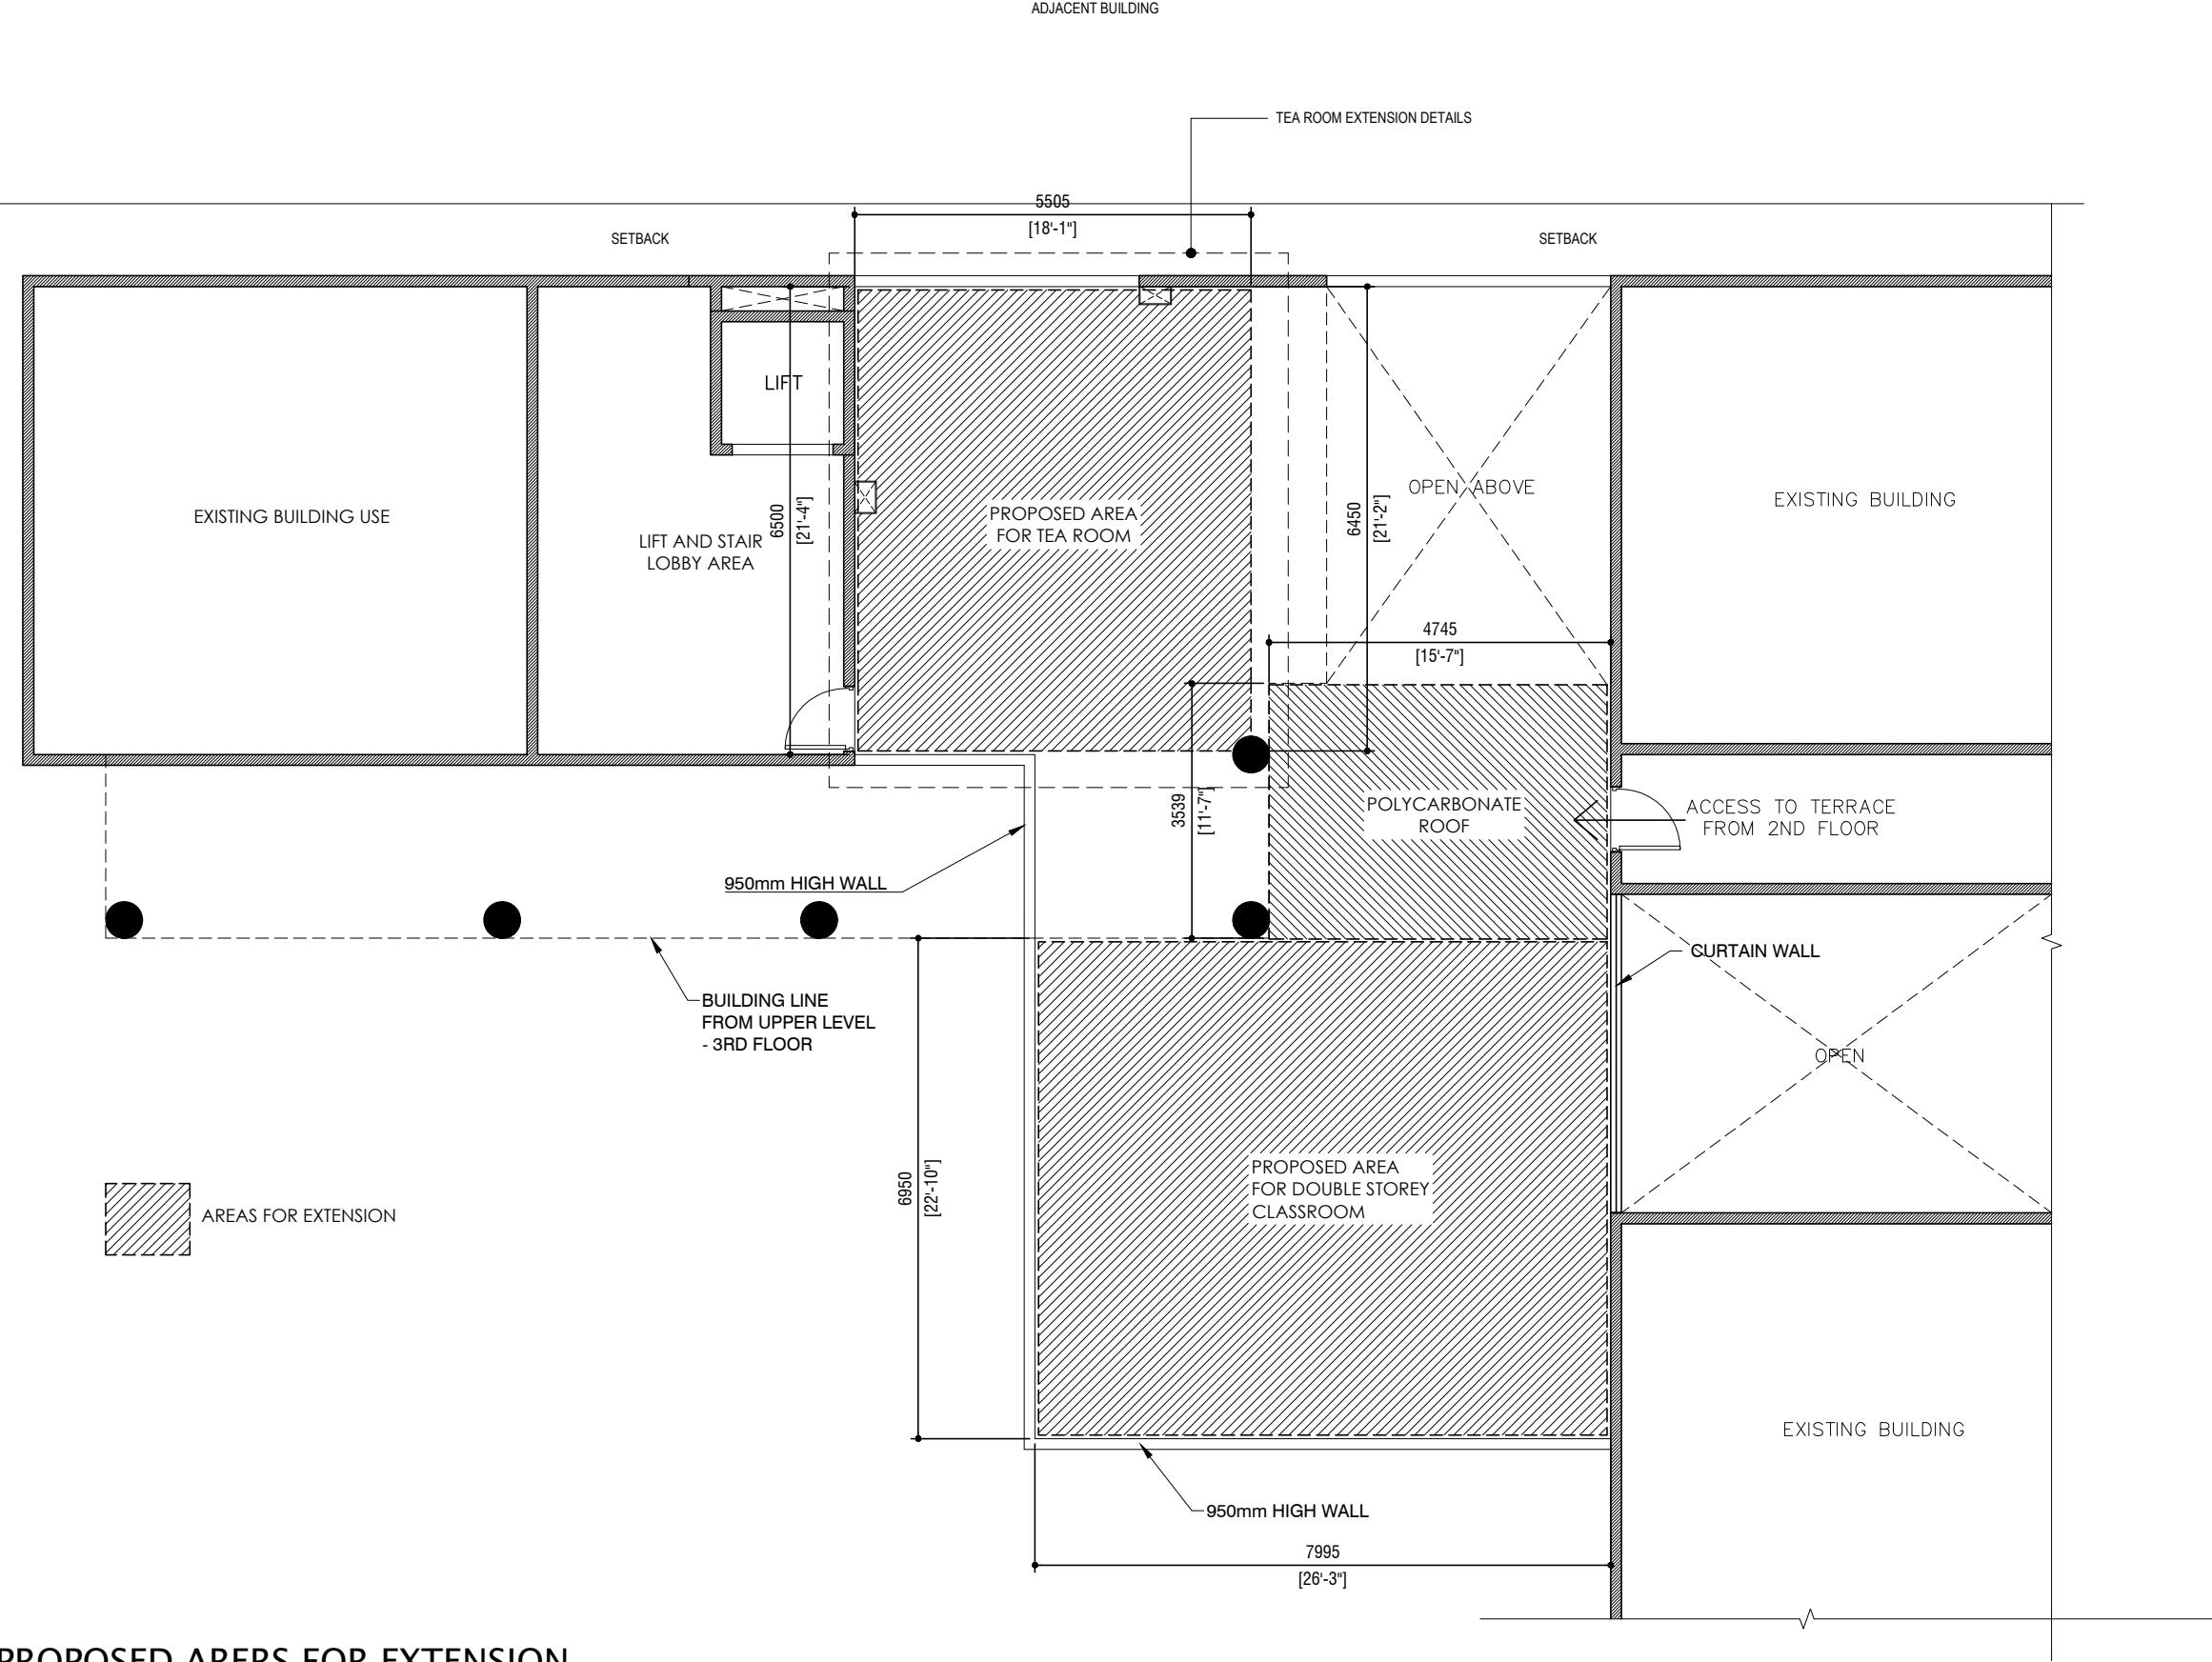



PROPOSED AREAS FOR EXTENSION

SCALE 1:100




PROJECT: PROPOSED 2 STOREY CLASSROOM EXTENSION & TEA ROOM LOCATION: MALE, MALDIVES CLIENT: MNU	DISCIPLINE: ARCHITECTURAL DRAWING TITLE: PROPOSED AREAS FOR EXTENSION	PAPER SIZE SCALE DATE	A3 1:100 13 JUNE 2026
		SHEET NO: A101	

TEA ROOM EXTENSION DETAILS

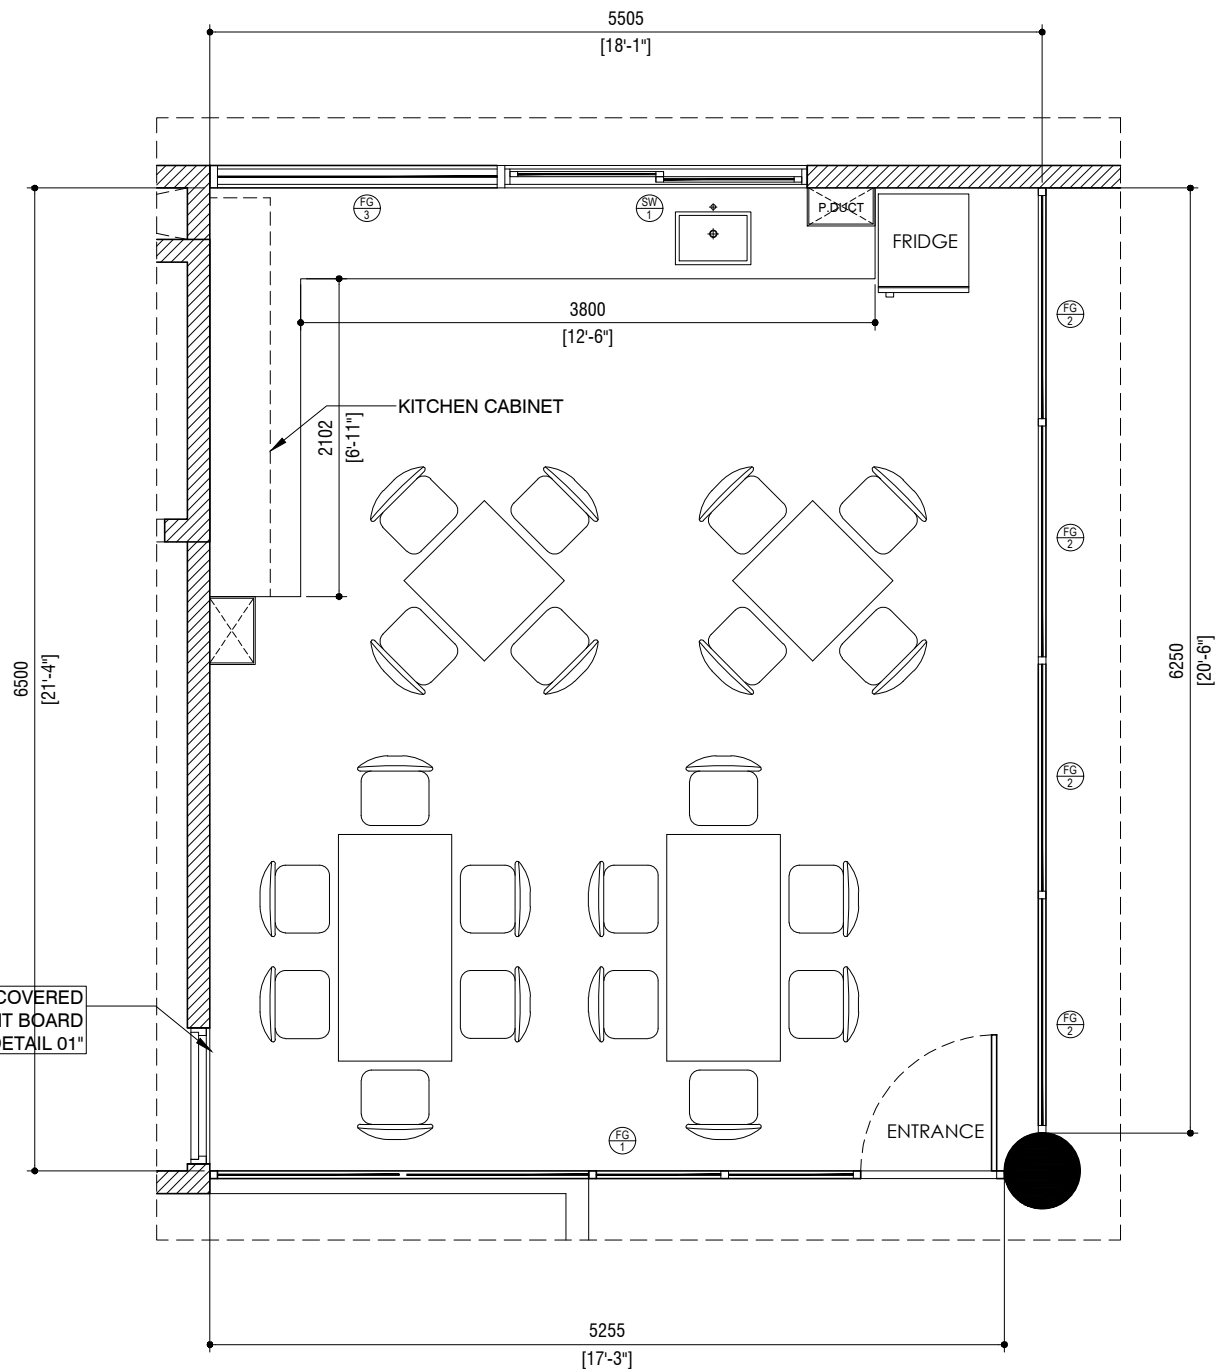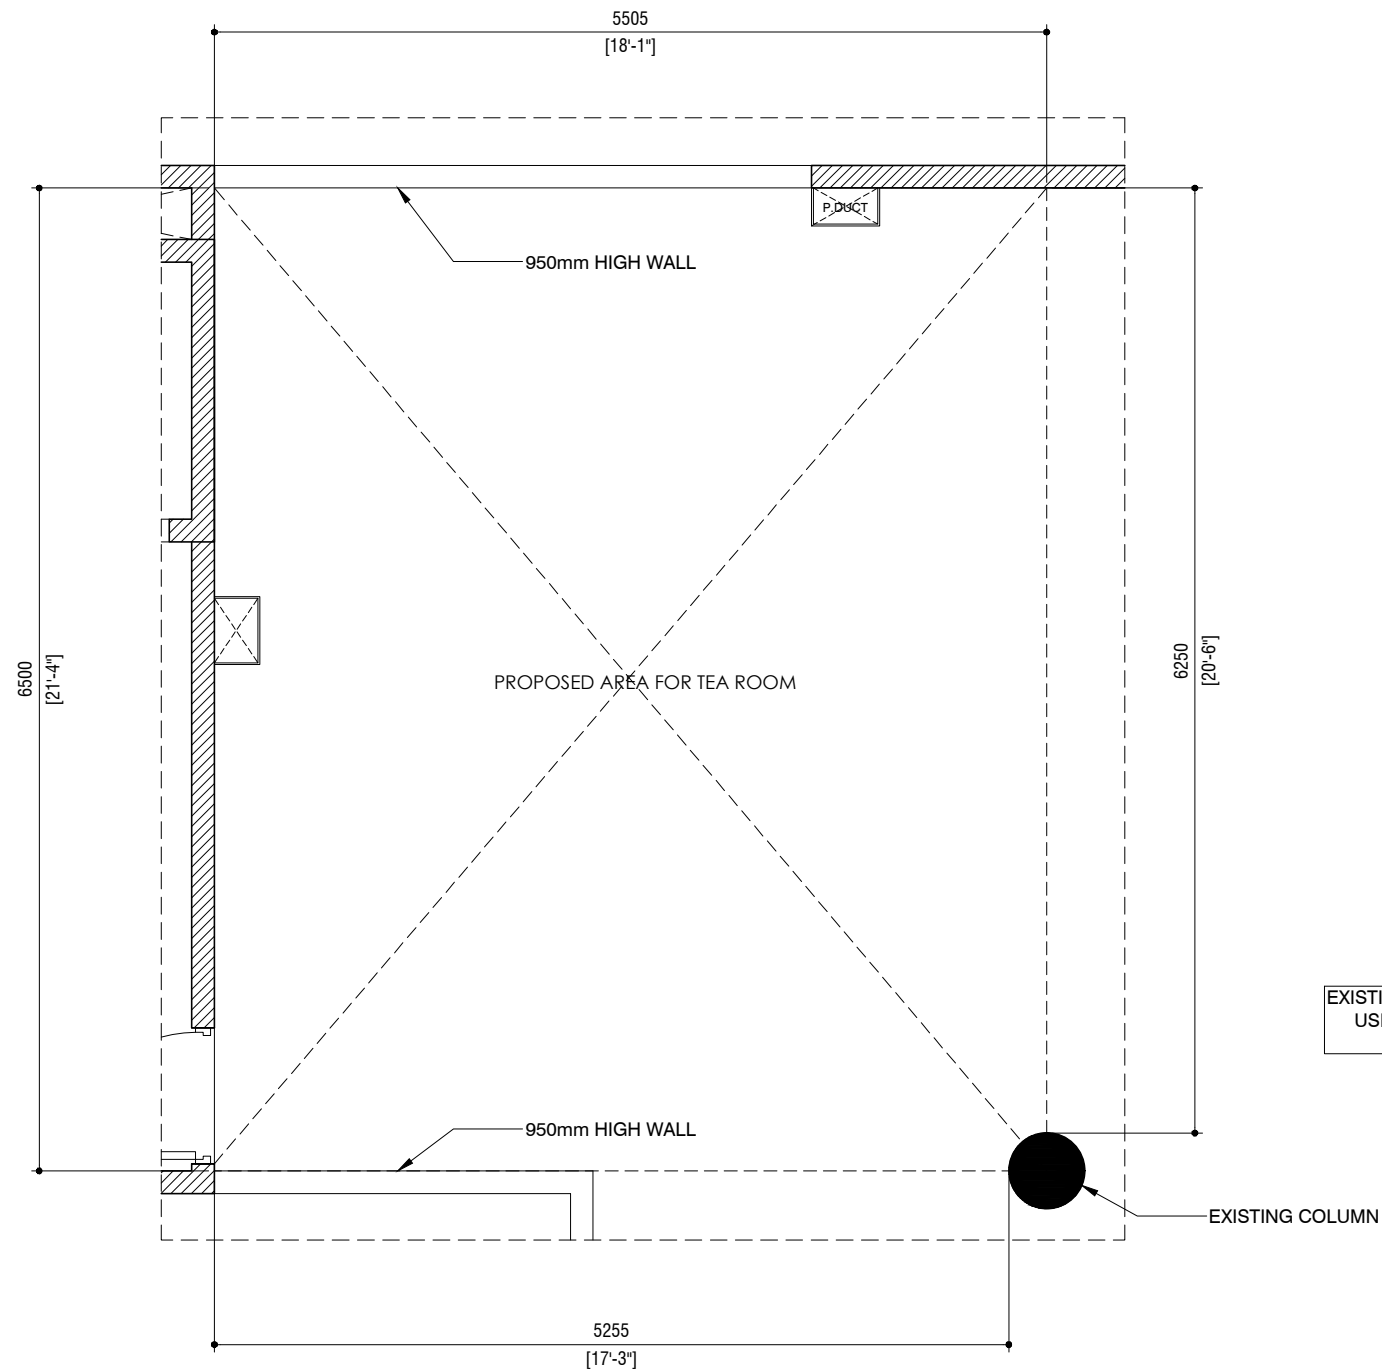

- DETAIL 01 - NOTE
- COVER EXISTING ACCESS DOOR WITH CEMENT BOARD, SECURELY FIXED TO FRAME.
 - FINISH FLUSH WITH EXISTING WALL.
 - APPLY FILLER/PUTTY TO ACHIEVE SMOOTH SURFACE.
 - SAND SMOOTH AND PAINT TO MATCH APPROVED EXISTING WALL COLOR.

PROJECT: PROPOSED 2 STOREY CLASSROOM EXTENSION & TEA ROOM LOCATION: MALE, MALDIVES CLIENT: MNU	DISCIPLINE: ARCHITECTURAL DRAWING TITLE: EXISTING AND PROPOSED LAYOUT - TEA ROOM	PAPER SIZE SCALE DATE	A3 1:50 13 JUNE 2026
		SHEET NO: A102	

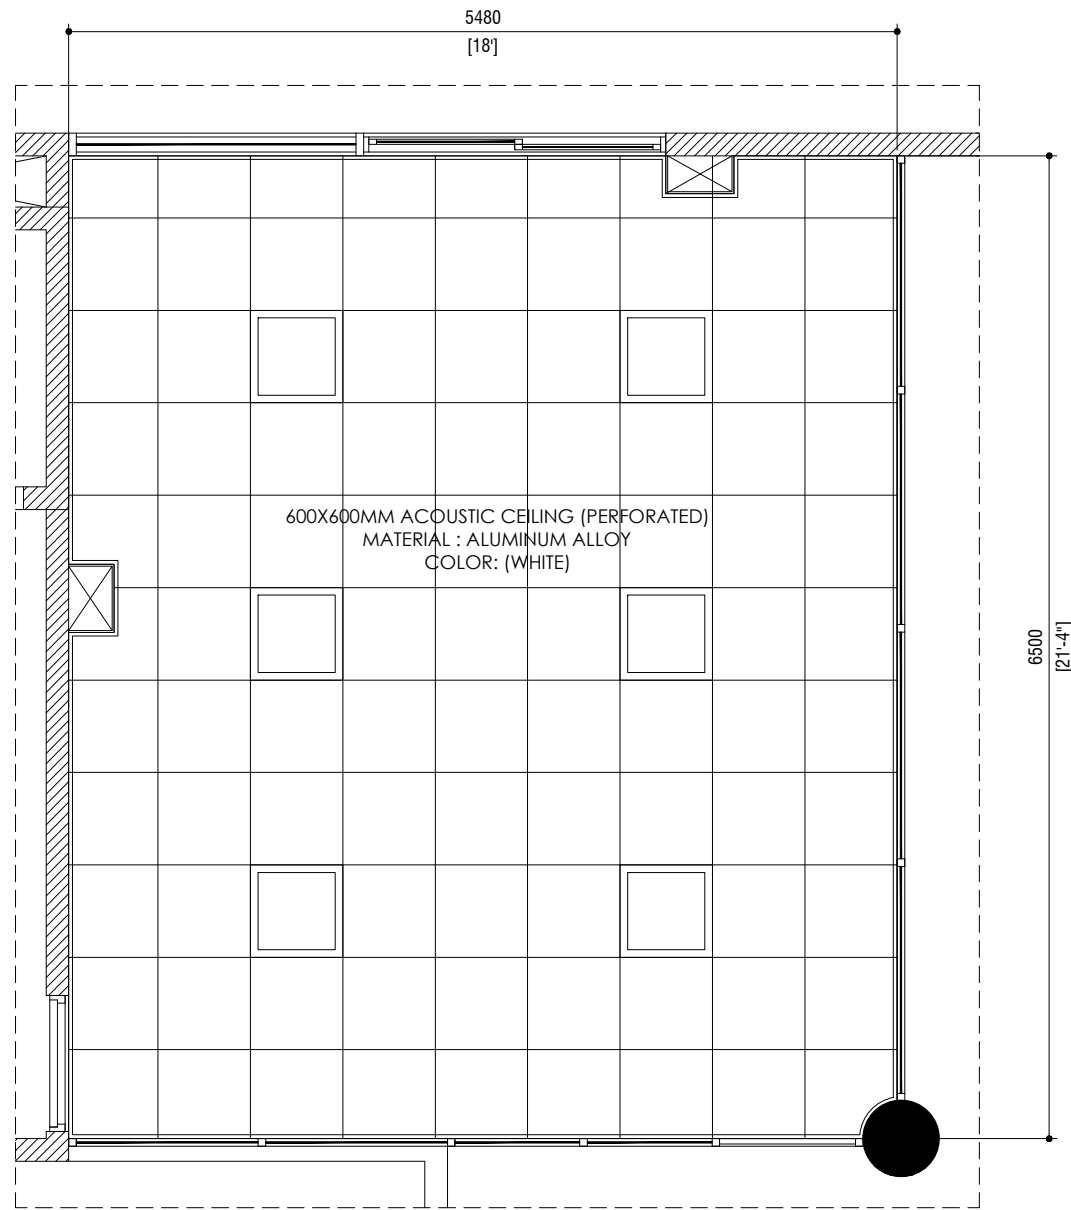


REFLECTED CEILING LAYOUT

SCALE 1:50



600x600mm LED RECESSED PANEL LIGHT

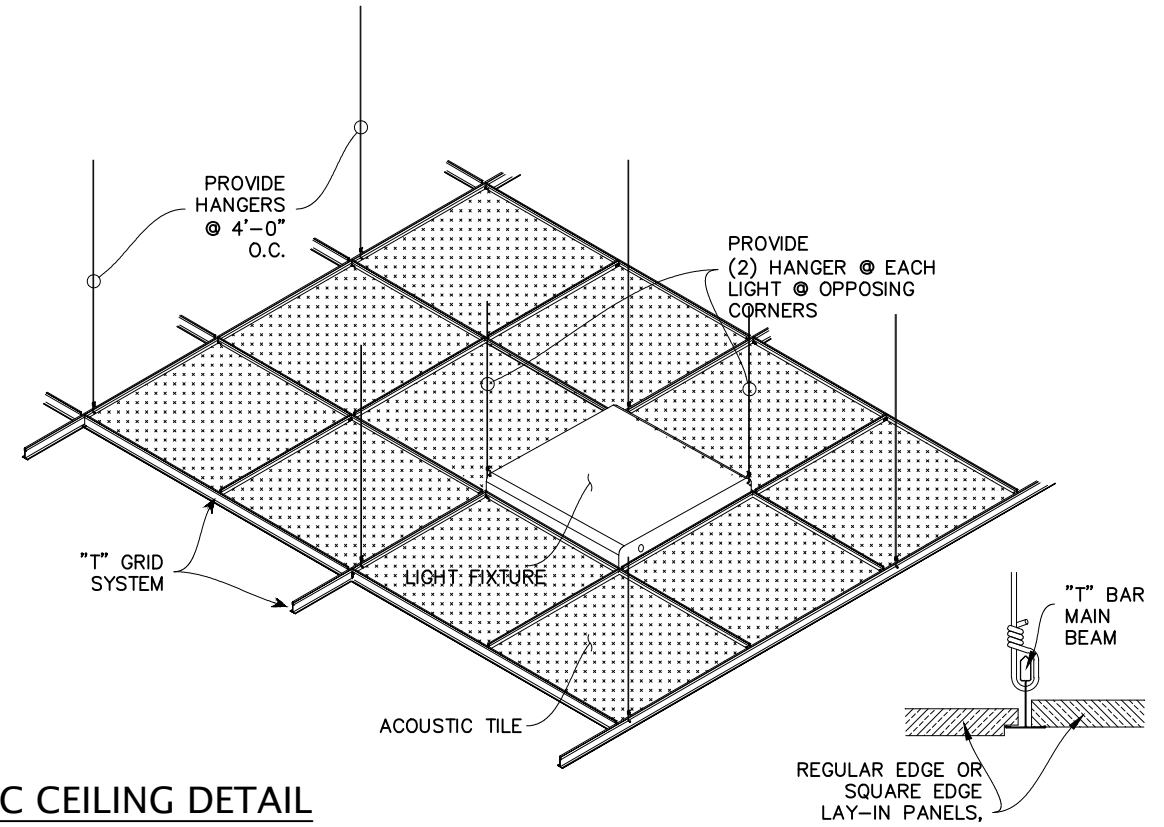

ACOUSTIC CEILING DETAIL

NTS

PROJECT: PROPOSED 2 STOREY CLASSROOM EXTENSION & TEA ROOM LOCATION: MALE, MALDIVES CLIENT: MNU	DISCIPLINE: ARCHITECTURAL DRAWING TITLE: REFLECTED CEILING LAYOUT & DETAILS	PAPER SIZE SCALE DATE	A3 1:50 13 JUNE 2026
		SHEET NO: A103	

SYMBOL	FG 3 SD 1
OPENING AREA	1.47m ²
PLAN VIEW	
ELEVATION	
LOCATION	TEA ROOM
QUANTITY	01
DOOR FRAME	POWDER COATED ALUM.
DOOR PANEL	PDR COARED ALUM WITH 6mm GLASS
LOCK/HINGES	LOCK X 1
FINISHES	WHITE
REMARKS	6mm FIXED GLASS

DOOR/ WINDOW SCHEDULE 02

SCALE 1:50



NOTE:

- ALL MEASUREMENTS ARE IN MILLIMETER (MM)
- ALL MEASUREMENTS TO BE CHECKED ON SITE PRIOR TO FABRICATION
- RC LINTEL AND SILL BEAMS TO BE PROVIDED AT THE TOP AND BOTTOM (WHERE THE DOOR / WINDOW OPENINGS DO NOT TOUCH THE FLOOR OR AN RC STRUCTURAL SURFACE)
- ALL TEMPERED GLASS IN 6MM
- ALL TIMBER DOOR FRAMES IN SOLID WOOD, PUTTY SMOOTH SANDED.
- DOOR SWING DIRECTIONS ARE AS PER PLANS.


T	--	TIMBER
G	--	GLASS
TG	--	TEMPERED GLASS
TL	--	TIMBER LOUVERED
GL	--	GLASS LOUVERED
A	--	ALUMINUM
PVC	--	PLASTIC
WPC	--	WOOD PLASTIC COMPOSITE
S.S	--	STAINLESS STEEL
FB	--	FIBER BOARD
FRG	--	FROST GLASS
F.G	--	FIXED GLASS

PROJECT: PROPOSED 2 STOREY CLASSROOM EXTENSION & TEA ROOM LOCATION: MALE, MALDIVES CLIENT: MNU	DISCIPLINE: ARCHITECTURAL DRAWING TITLE: DOOR WINDOW DETAILS	<table><tr><td> PAPER SIZE SCALE DATE </td><td> A3 1:50 13 JUNE 2026 </td></tr><tr><td colspan="2"> SHEET NO: A105 </td></tr></table>	PAPER SIZE SCALE DATE	A3 1:50 13 JUNE 2026	SHEET NO: A105	
PAPER SIZE SCALE DATE	A3 1:50 13 JUNE 2026					
SHEET NO: A105						


MEP DRAWINGS

TEA ROOM


13 JUNE 2026

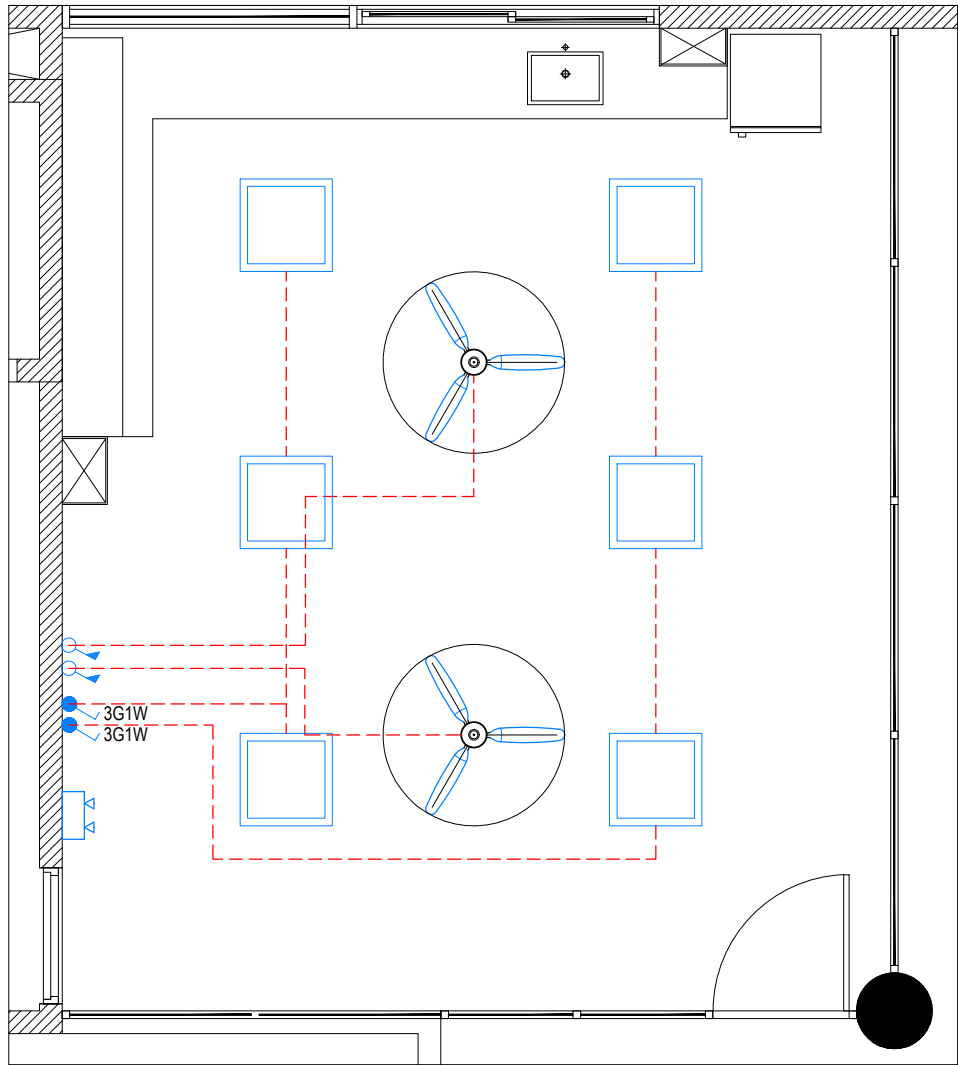


TEA ROOM ELECTRICAL LAYOUT
SCALE 1:50

 

SYMBOL	DESCRIPTION
	600x600MM LED RECESSED CEILING LIGHT PANEL
	CEILING FAN - 48 INCH DIA.
	EMERGENCY LIGHT
	FAN REGULATOR
	LIGHT SWITCH
	ELECTRICAL WIRING

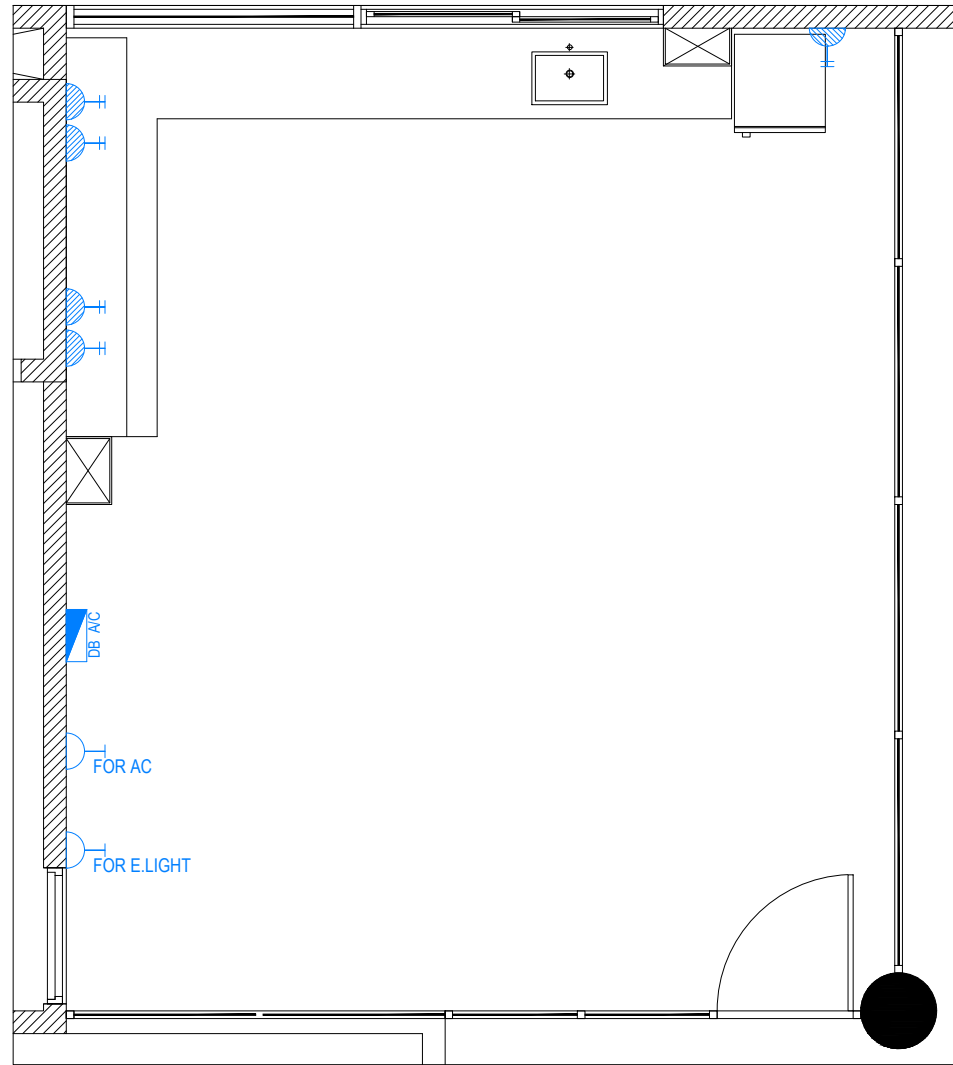


TEA ROOM POWER LAYOUT
SCALE 1:50

 


SYMBOL	DESCRIPTION
	DISTRIBUTION BOARD
	SINGLE SOCKET
	DOUBLE SOCKET
	SINGLE SOCKET @HL FOR AC, CAMERA, & E.LIGHTS

PROJECT: PROPOSED 2 STOREY CLASSROOM EXTENSION & TEA ROOM LOCATION: MALE, MALDIVES CLIENT: MNU	DISCIPLINE: ARCHITECTURAL DRAWING TITLE: TEA ROOM ELECTRICAL & POWER LAYOUT	PAPER SIZE SCALE DATE	A3 1:50 13 JUNE 2026
		SHEET NO: M100	

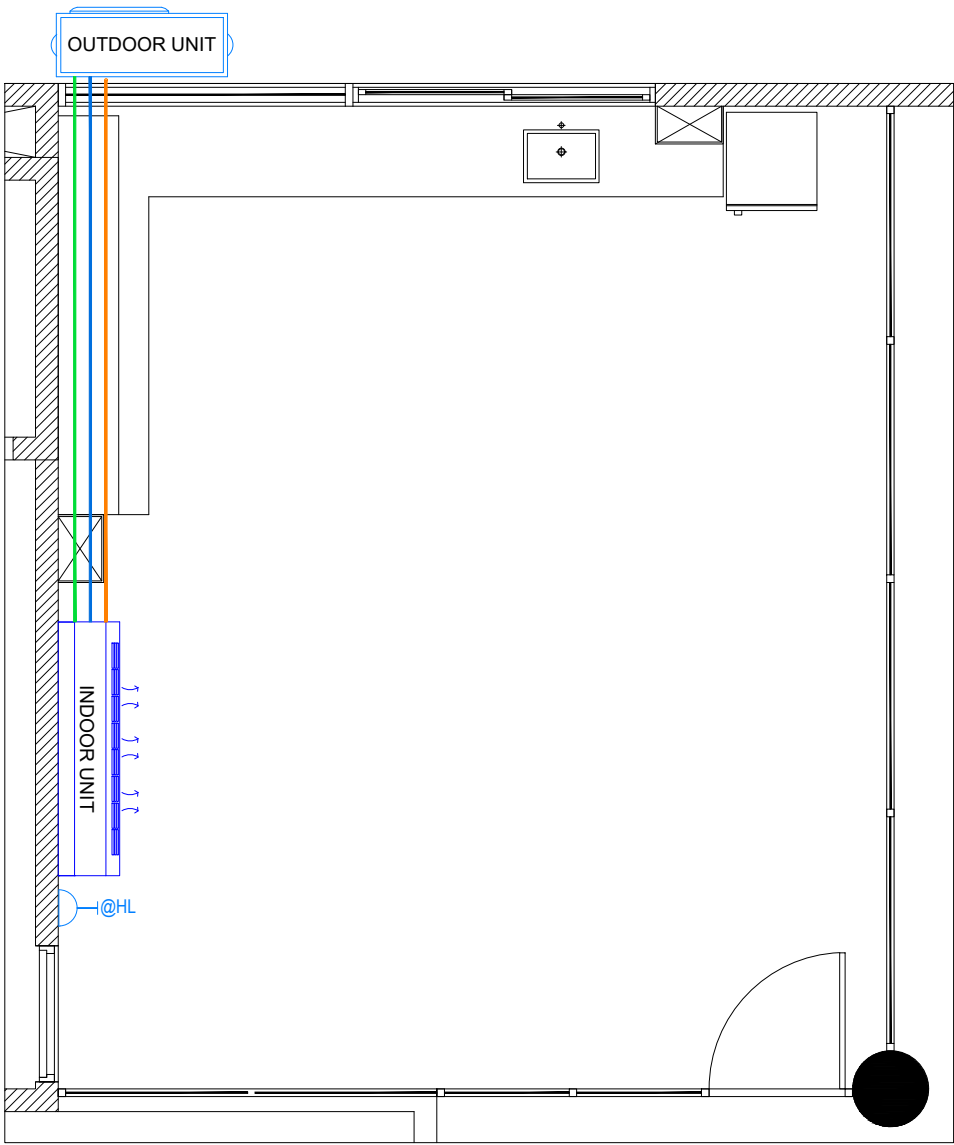


TEA ROOM AC LAYOUT

 SCALE 1:50




SYMBOL	DESCRIPTION
	INSULATED LIQUID PIPE
	INSULATED GAS PIPE
	DRAINAGE LINE
	FAN COIL UNIT
	CONDENSER UNIT
	SINGLE SOCKET OUTLET - 16A

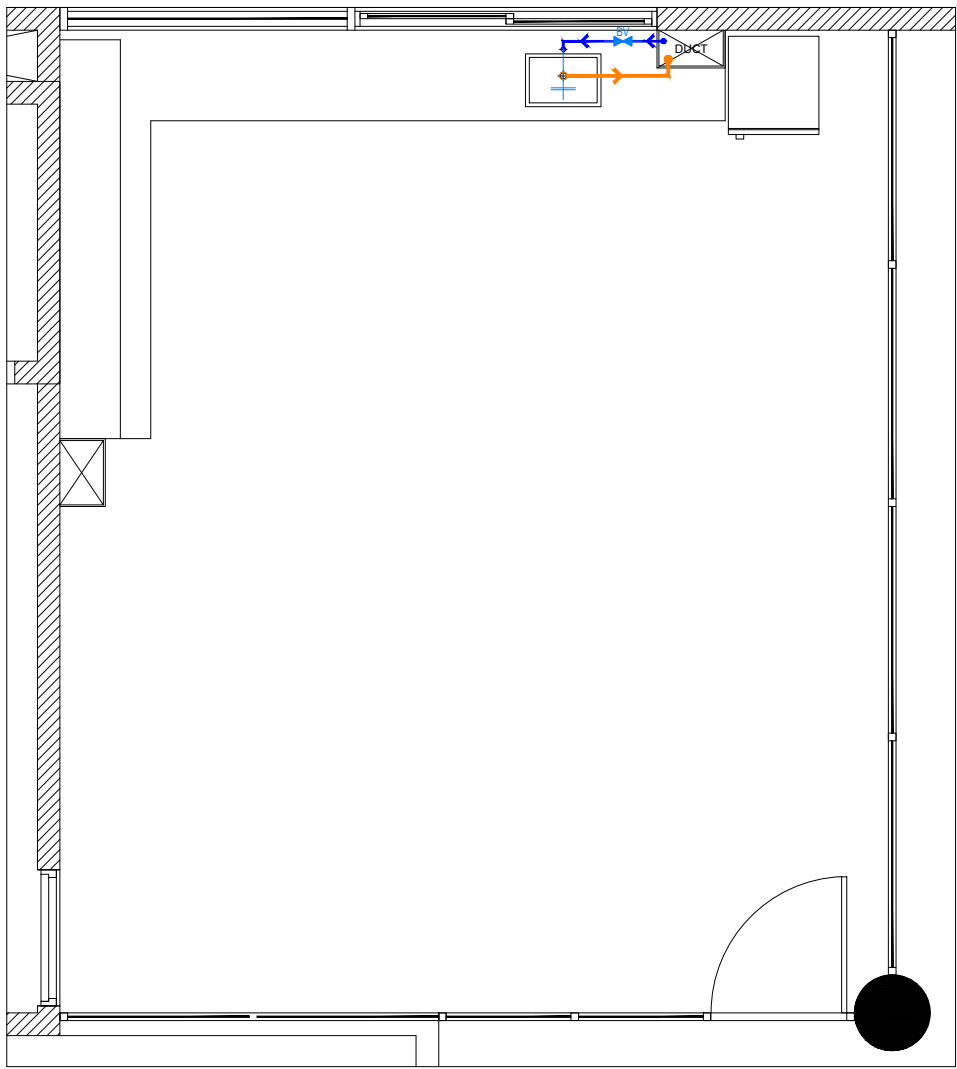

TEA ROOM WATER SUPPLY AND DRAINAGE LAYOUT

 SCALE 1:50




SYMBOL	DESCRIPTION
	WATER METER
	FRESH WATER SUPPLY PIPE - DIA.25mm PIPE
	BALL VALVE
	WATER TAP
	WASTE WATER LINE - DIA.50mm PIPE

PROJECT: PROPOSED 2 STOREY CLASSROOM EXTENSION & TEA ROOM	DISCIPLINE: ARCHITECTURAL	PAPER SIZE SCALE DATE	A3 1:50 13 JUNE 2026
LOCATION: MALE, MALDIVES CLIENT: MNU	DRAWING TITLE: AS GIVEN	SHEET NO:	M101


ARCHITECTURAL DRAWINGS

CLASSROOM BUILDING


13 JUNE 2026

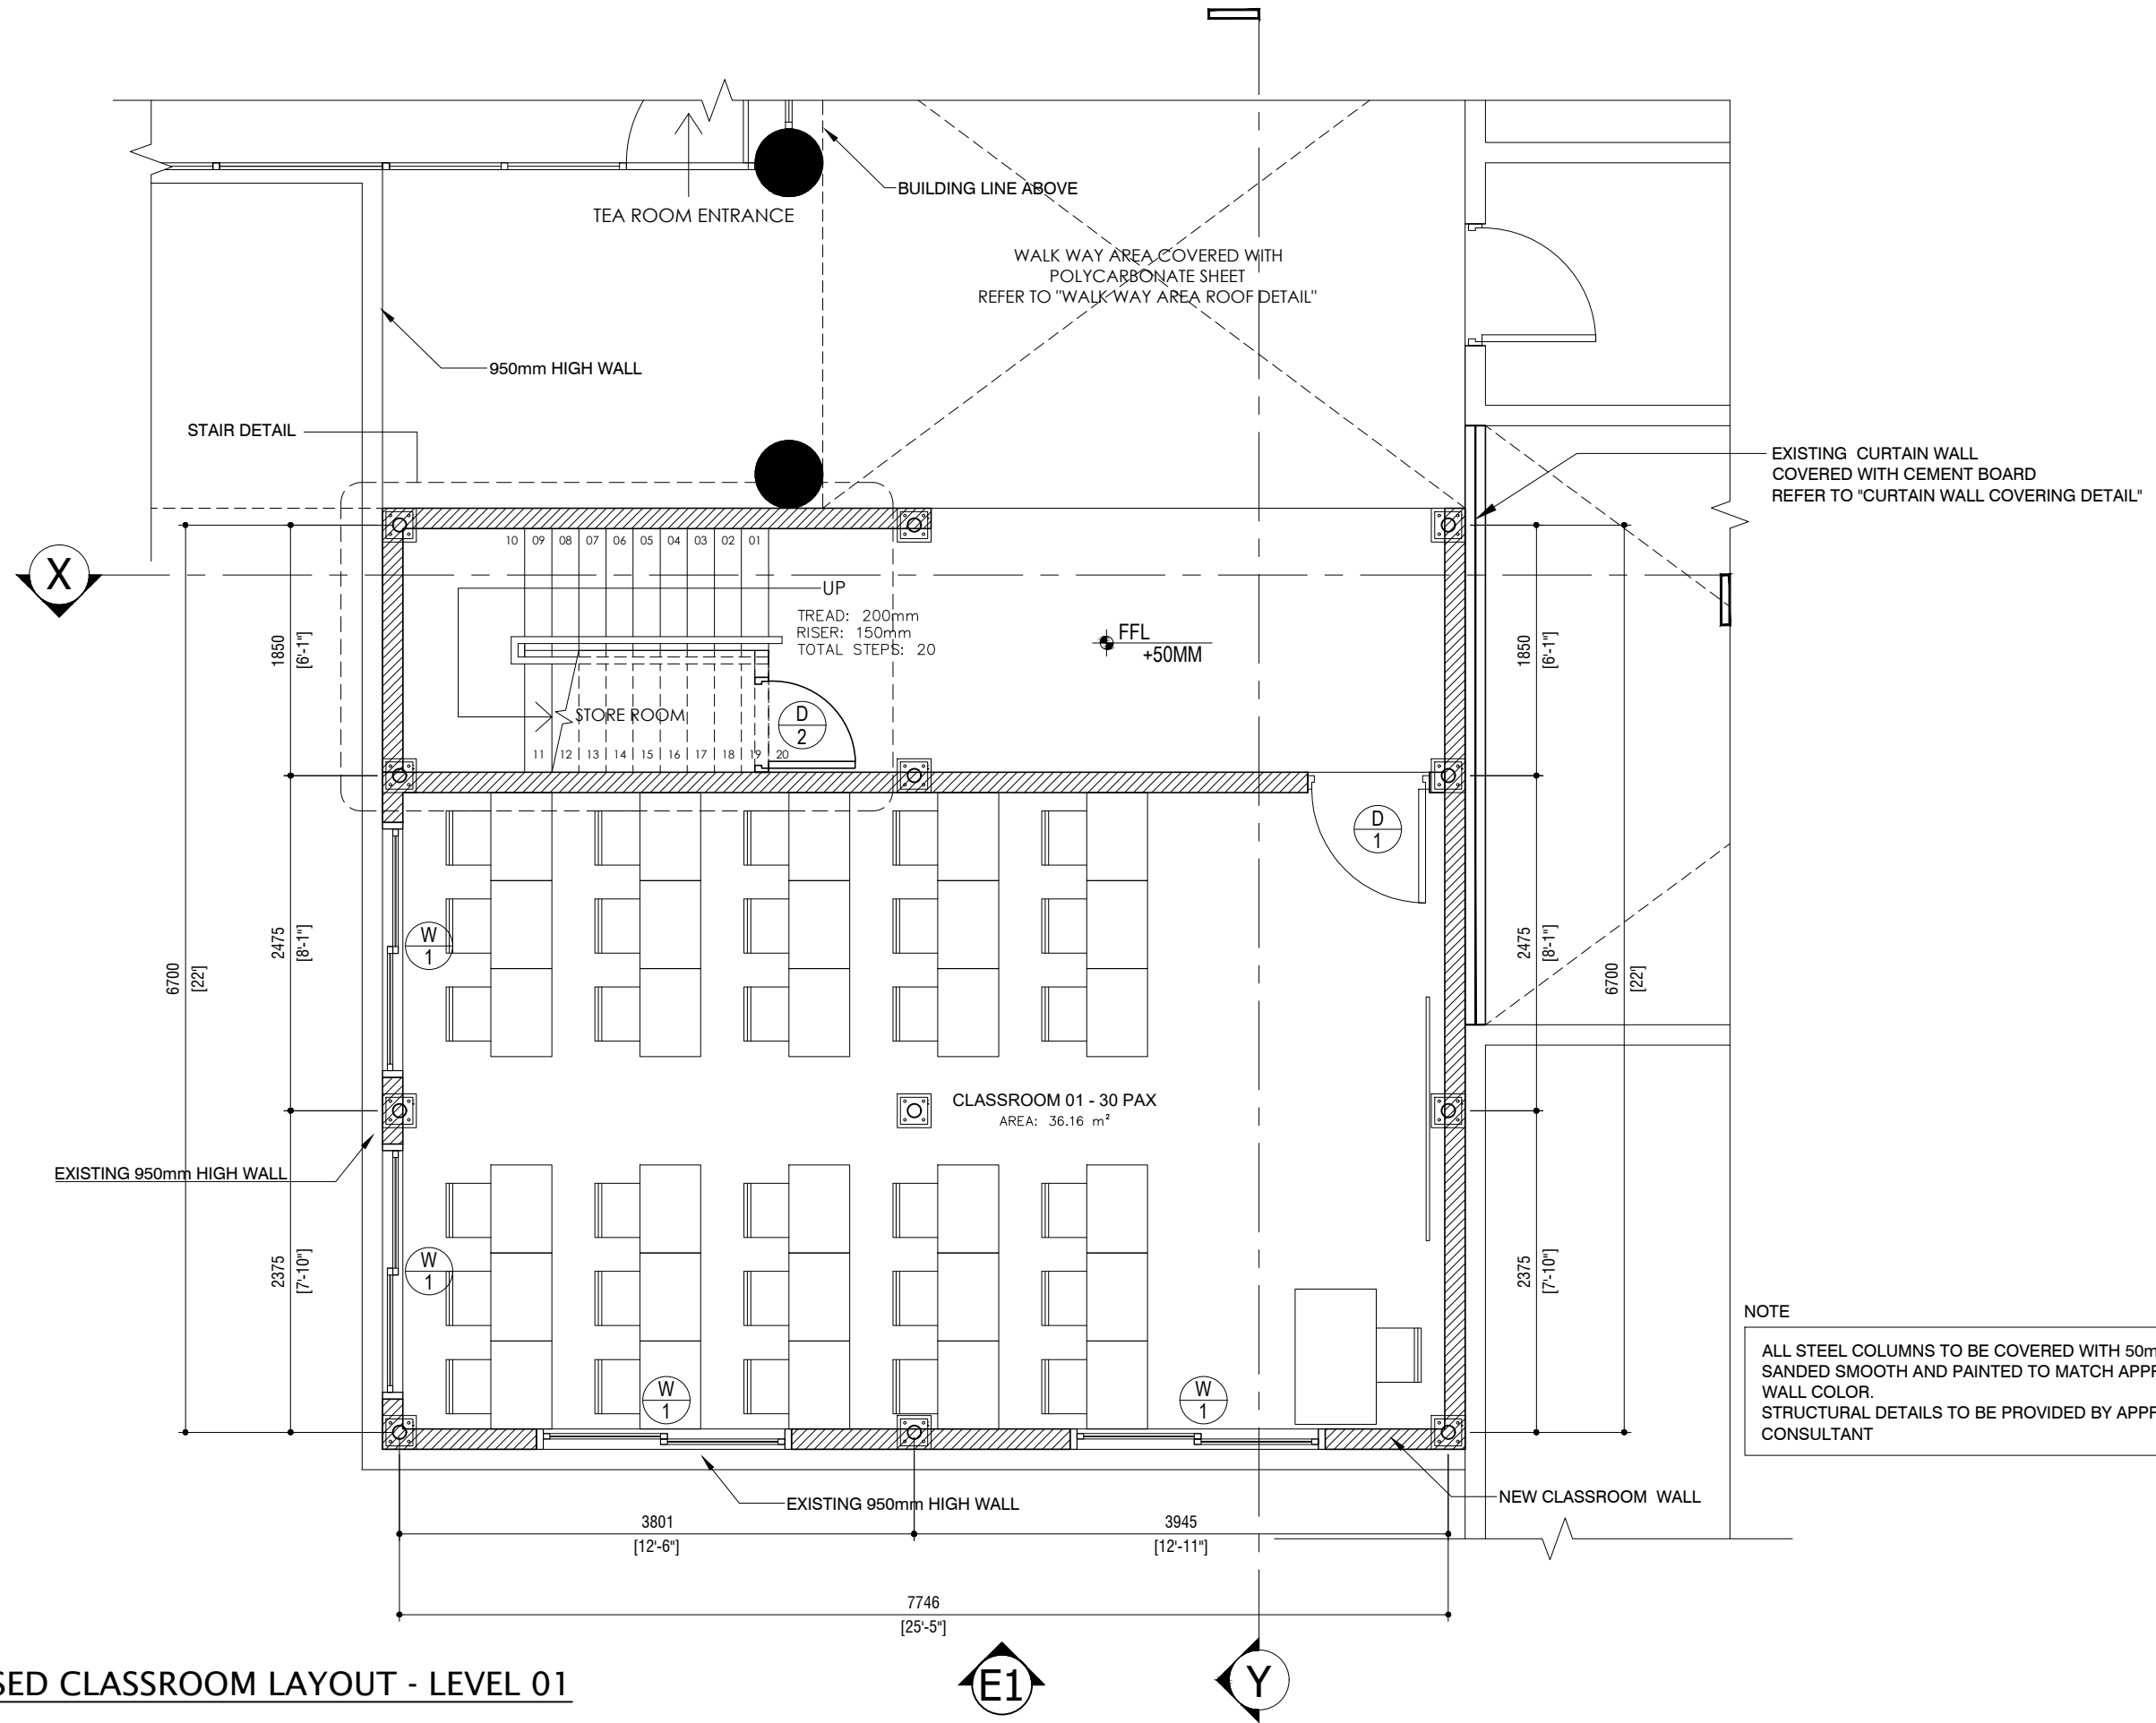

 
PROPOSED CLASSROOM LAYOUT - LEVEL 01
SCALE 1:50




PROJECT: PROPOSED 2 STOREY CLASSROOM EXTENSION & TEA ROOM LOCATION: MALE, MALDIVES CLIENT: MNU	DISCIPLINE: ARCHITECTURAL DRAWING TITLE: PROPOSED CLASSROOM LAYOUT - LEVEL 01	PAPER SIZE SCALE DATE	A3 1:50 13 JUNE 2026
		SHEET NO: A200	

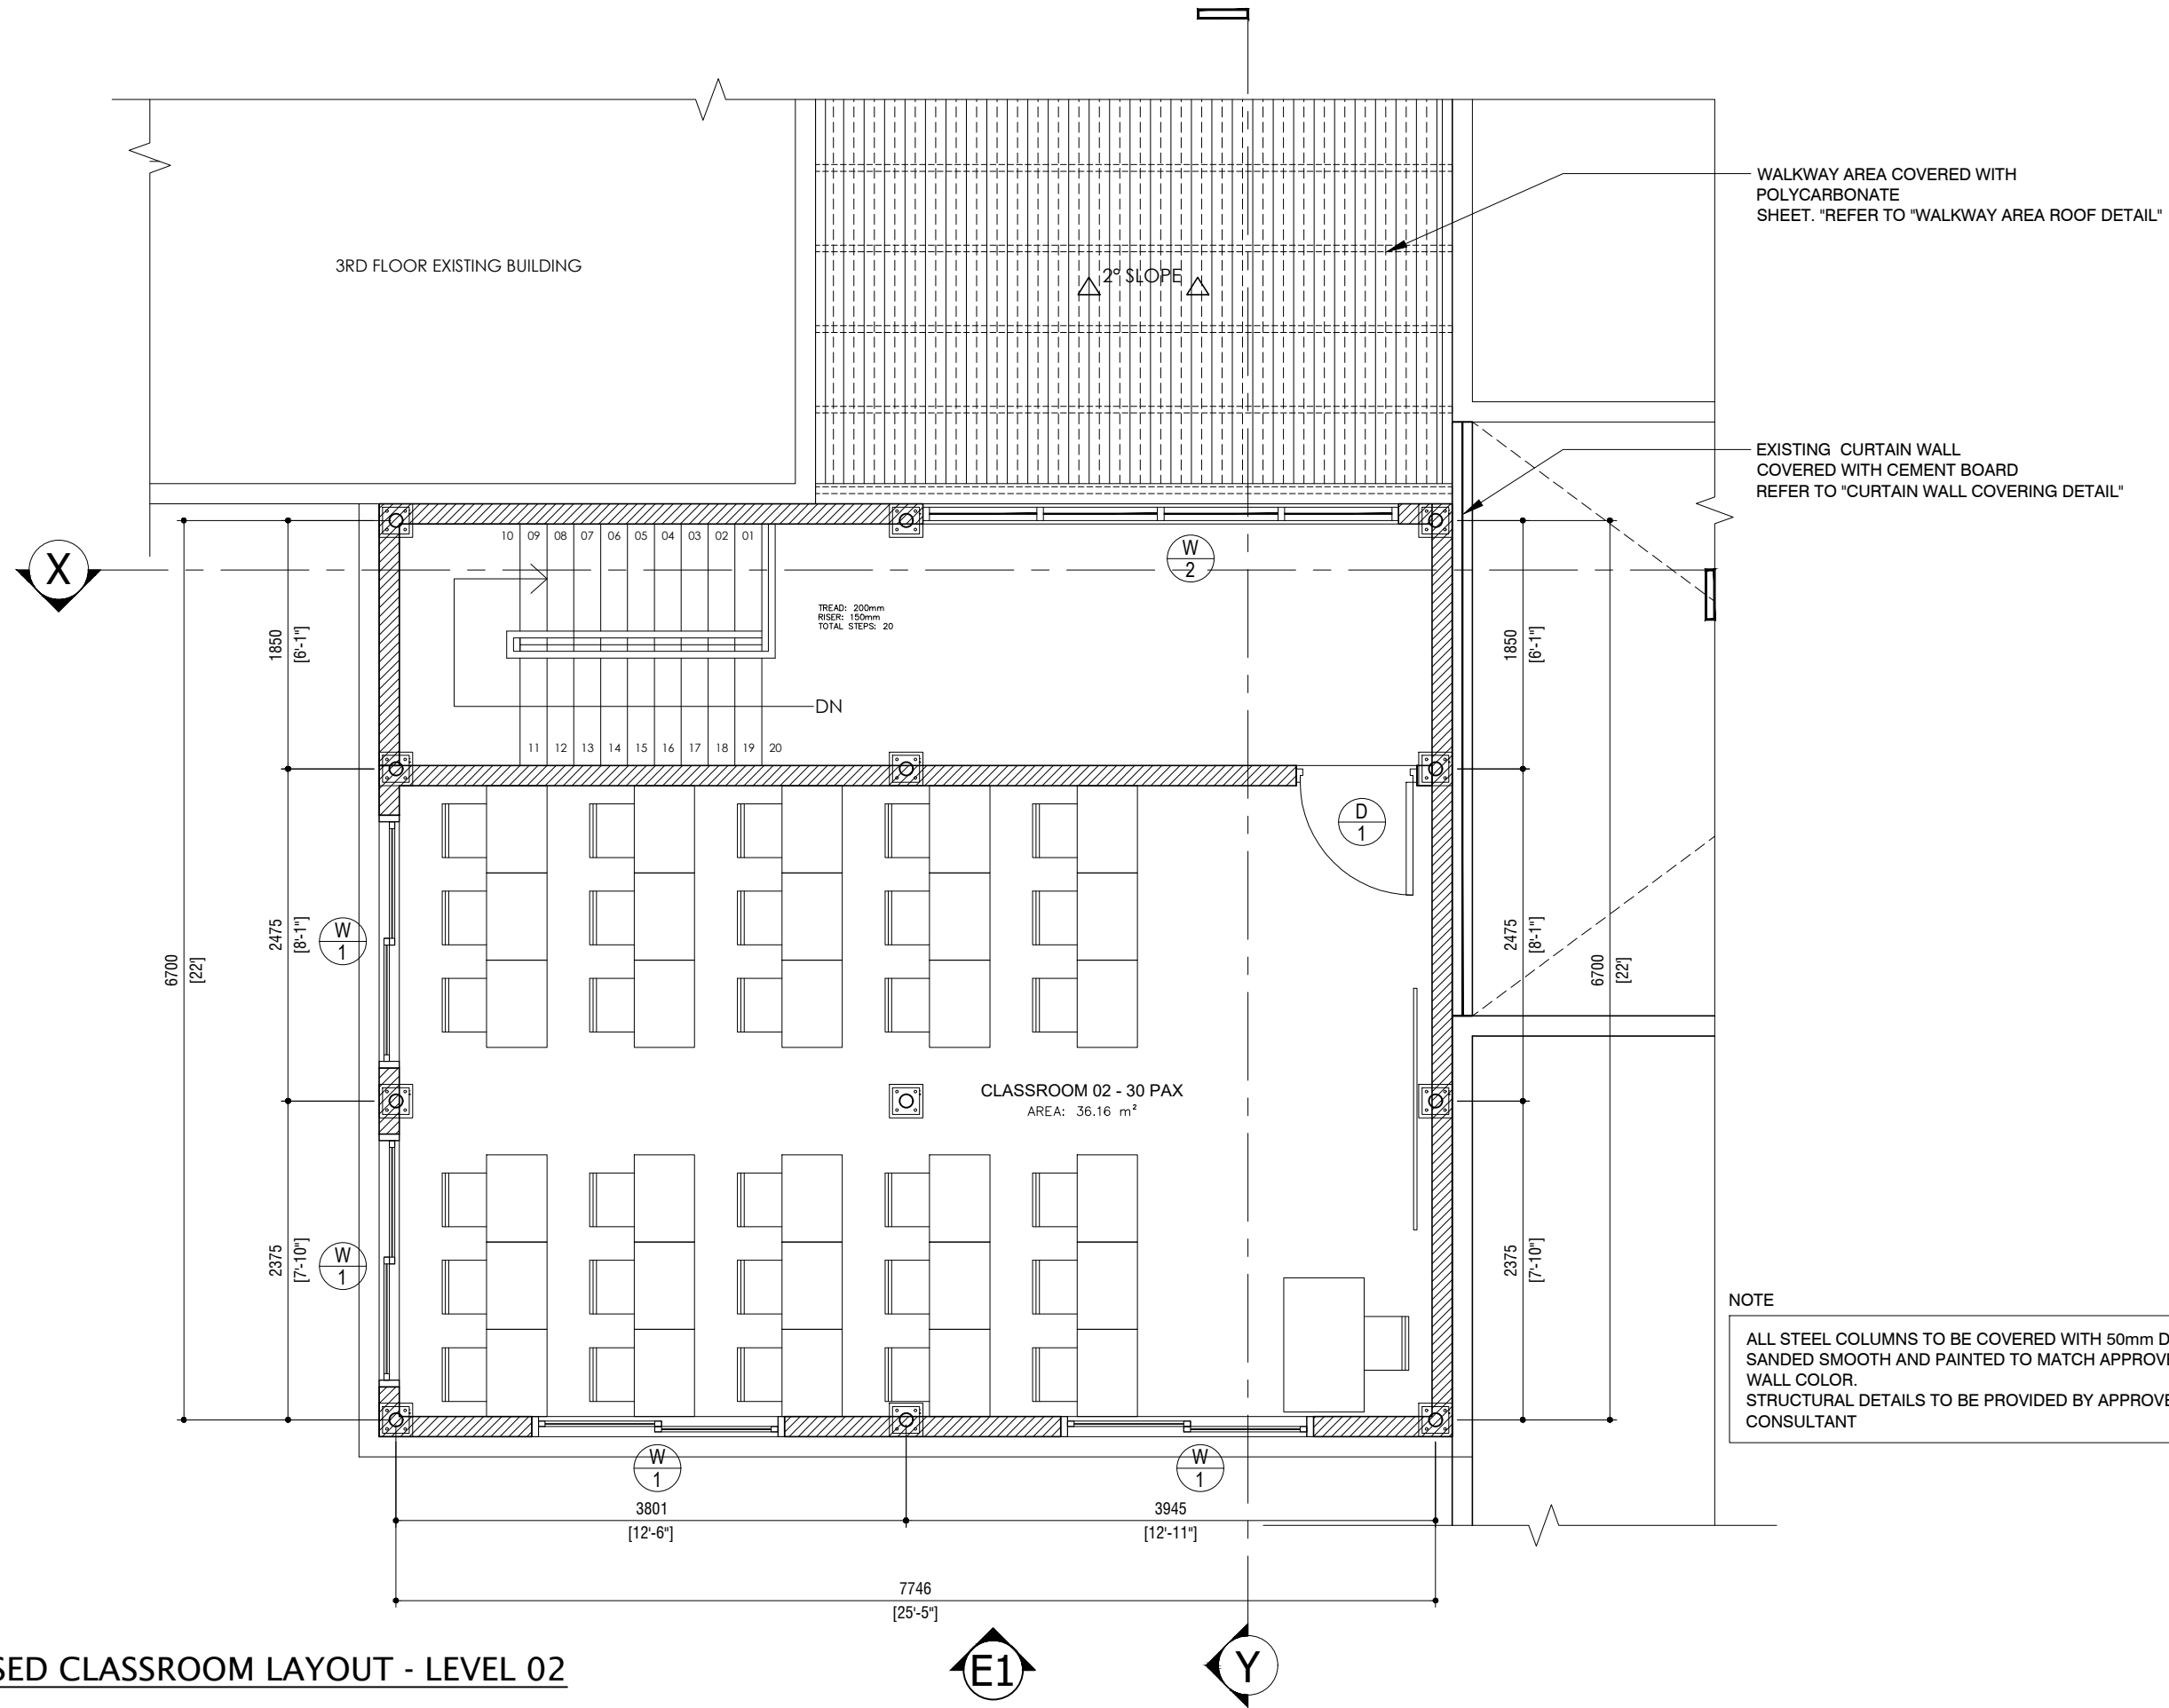

 PROPOSED CLASSROOM LAYOUT - LEVEL 02
SCALE 1:50




PROJECT: PROPOSED 2 STOREY CLASSROOM EXTENSION & TEA ROOM LOCATION: MALE, MALDIVES CLIENT: MNU	DISCIPLINE: ARCHITECTURAL DRAWING TITLE: PROPOSED CLASSROOM LAYOUT - LEVEL 02	PAPER SIZE SCALE DATE	A3 1:50 13 JUNE 2026
		SHEET NO: A201	

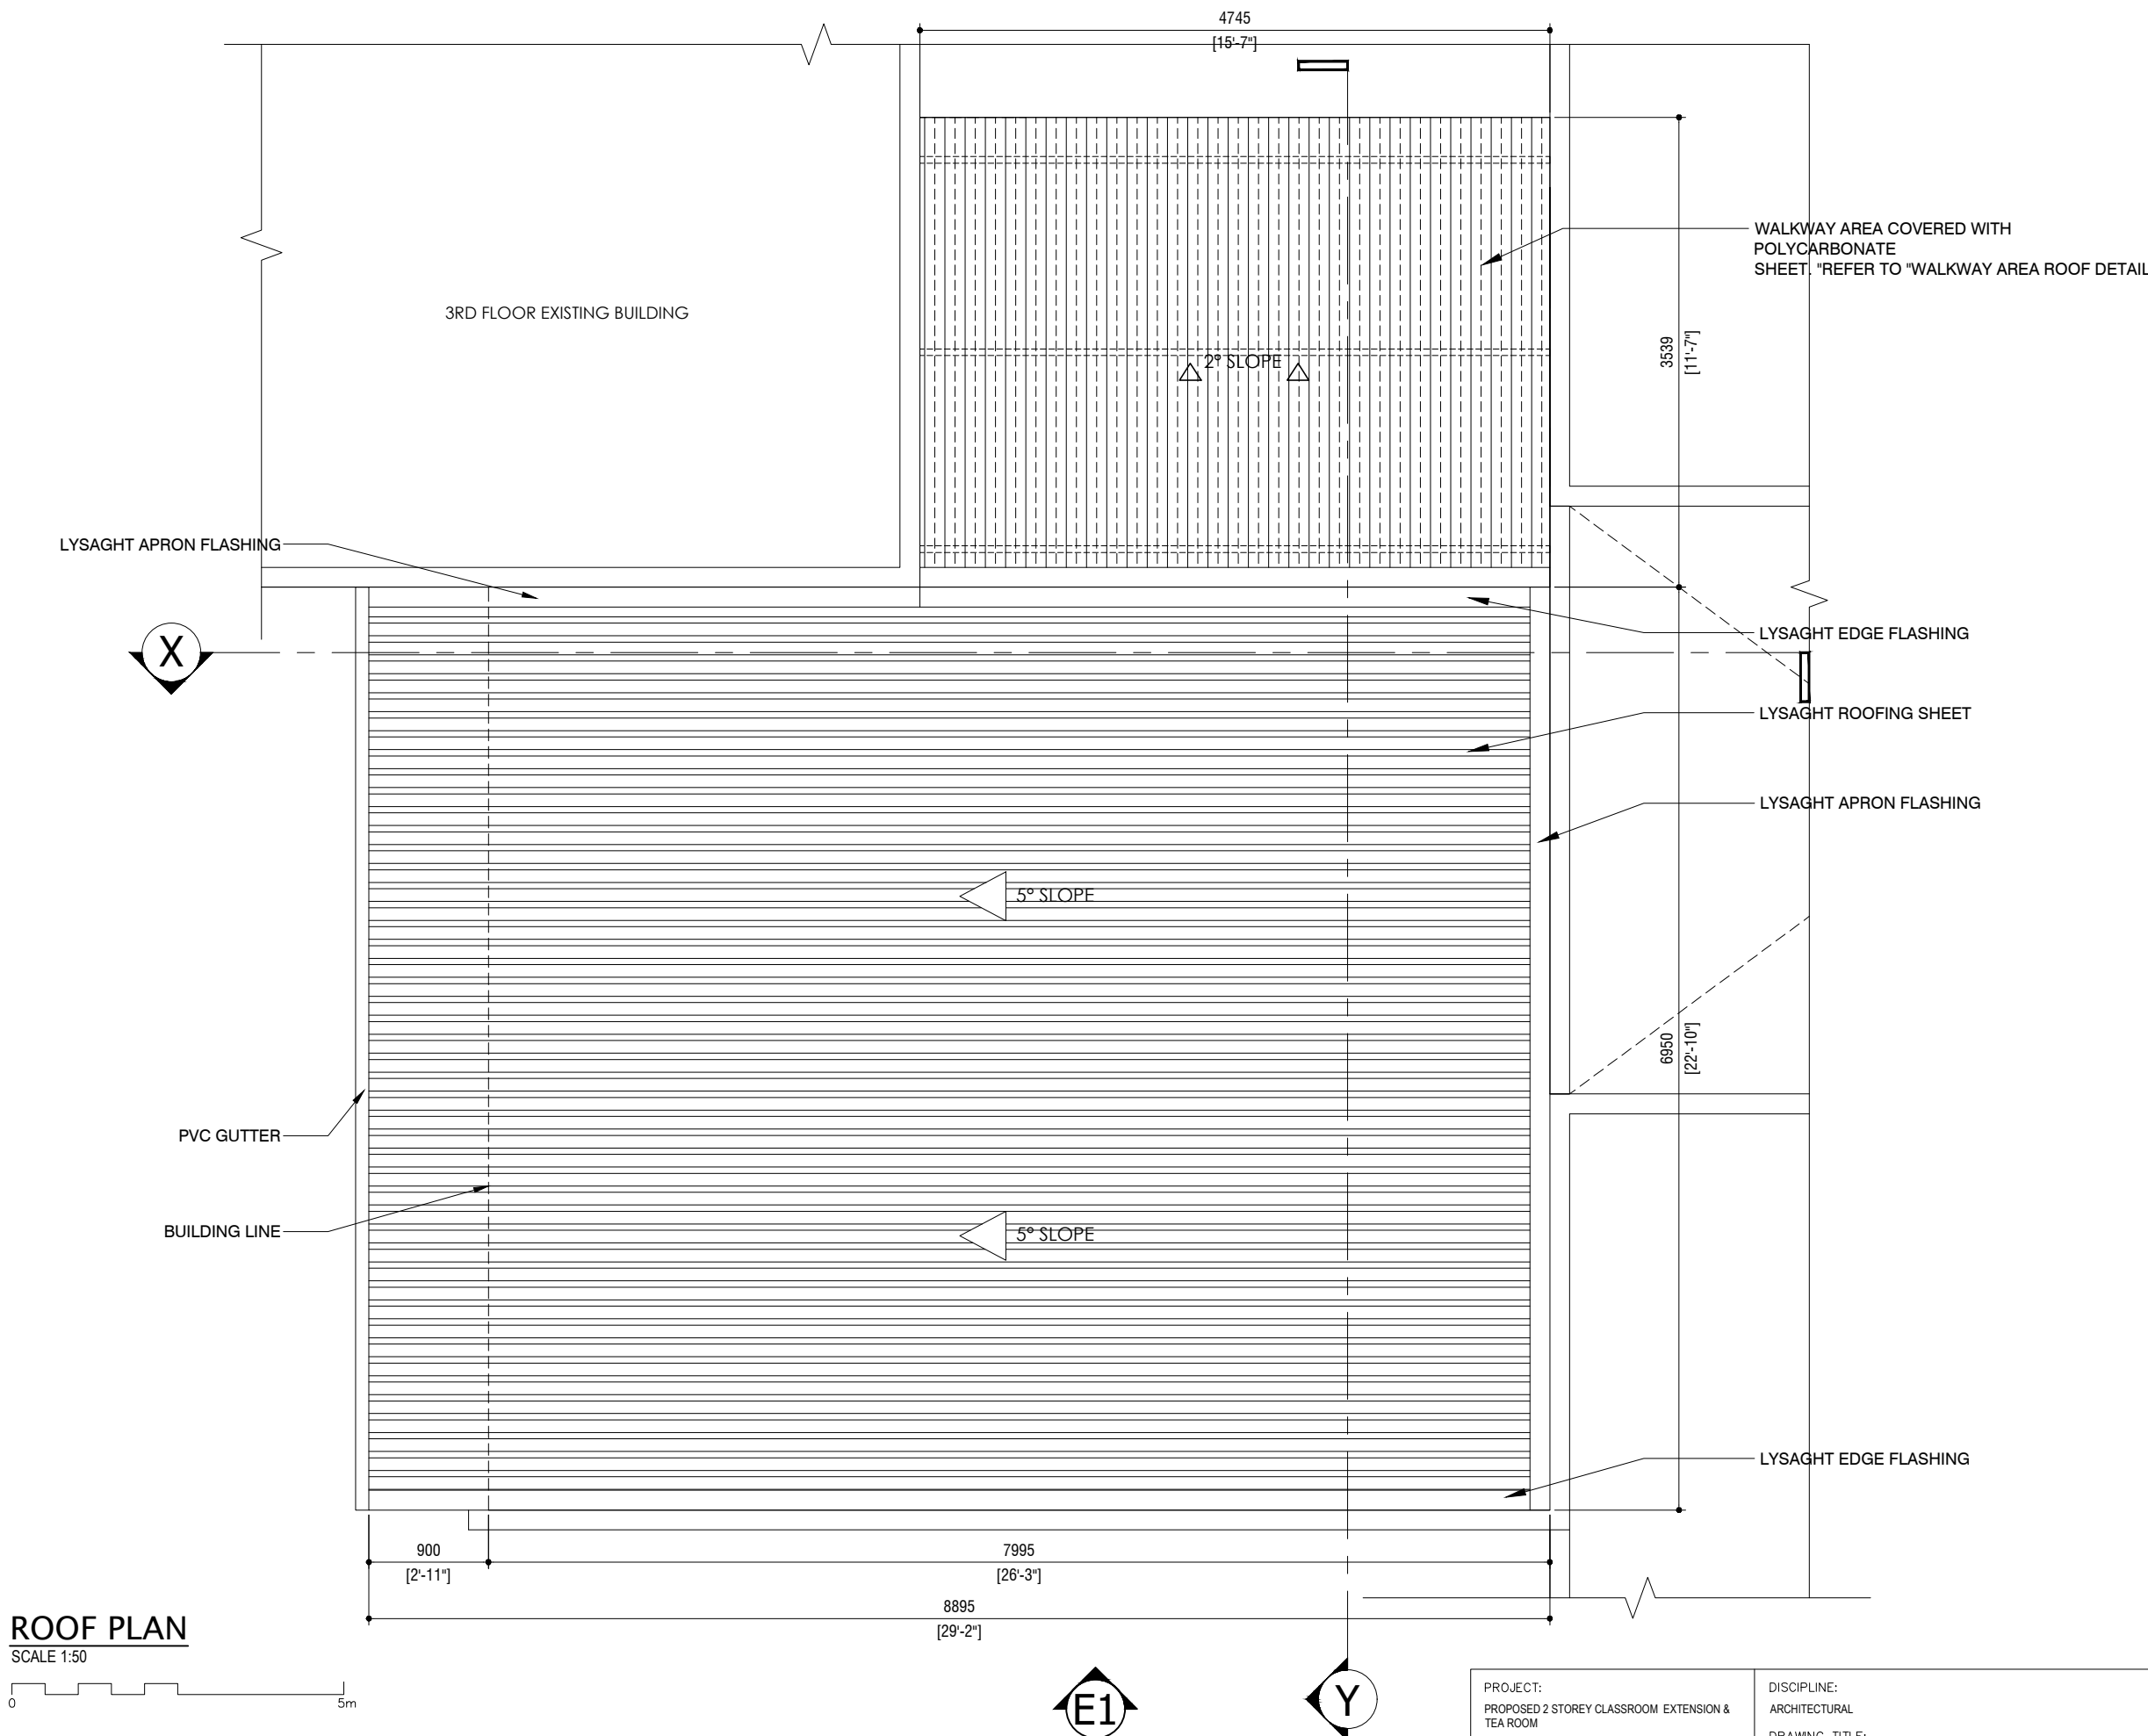


ROOF PLAN
SCALE 1:50




PROJECT: PROPOSED 2 STOREY CLASSROOM EXTENSION & TEA ROOM	DISCIPLINE: ARCHITECTURAL	PAPER SIZE SCALE DATE	A3 1:50 13 JUNE 2026
LOCATION: MALE, MALDIVES CLIENT: MNU	DRAWING TITLE: PROPOSED CLASSROOM LAYOUT - LEVEL 02	SHEET NO: A202	

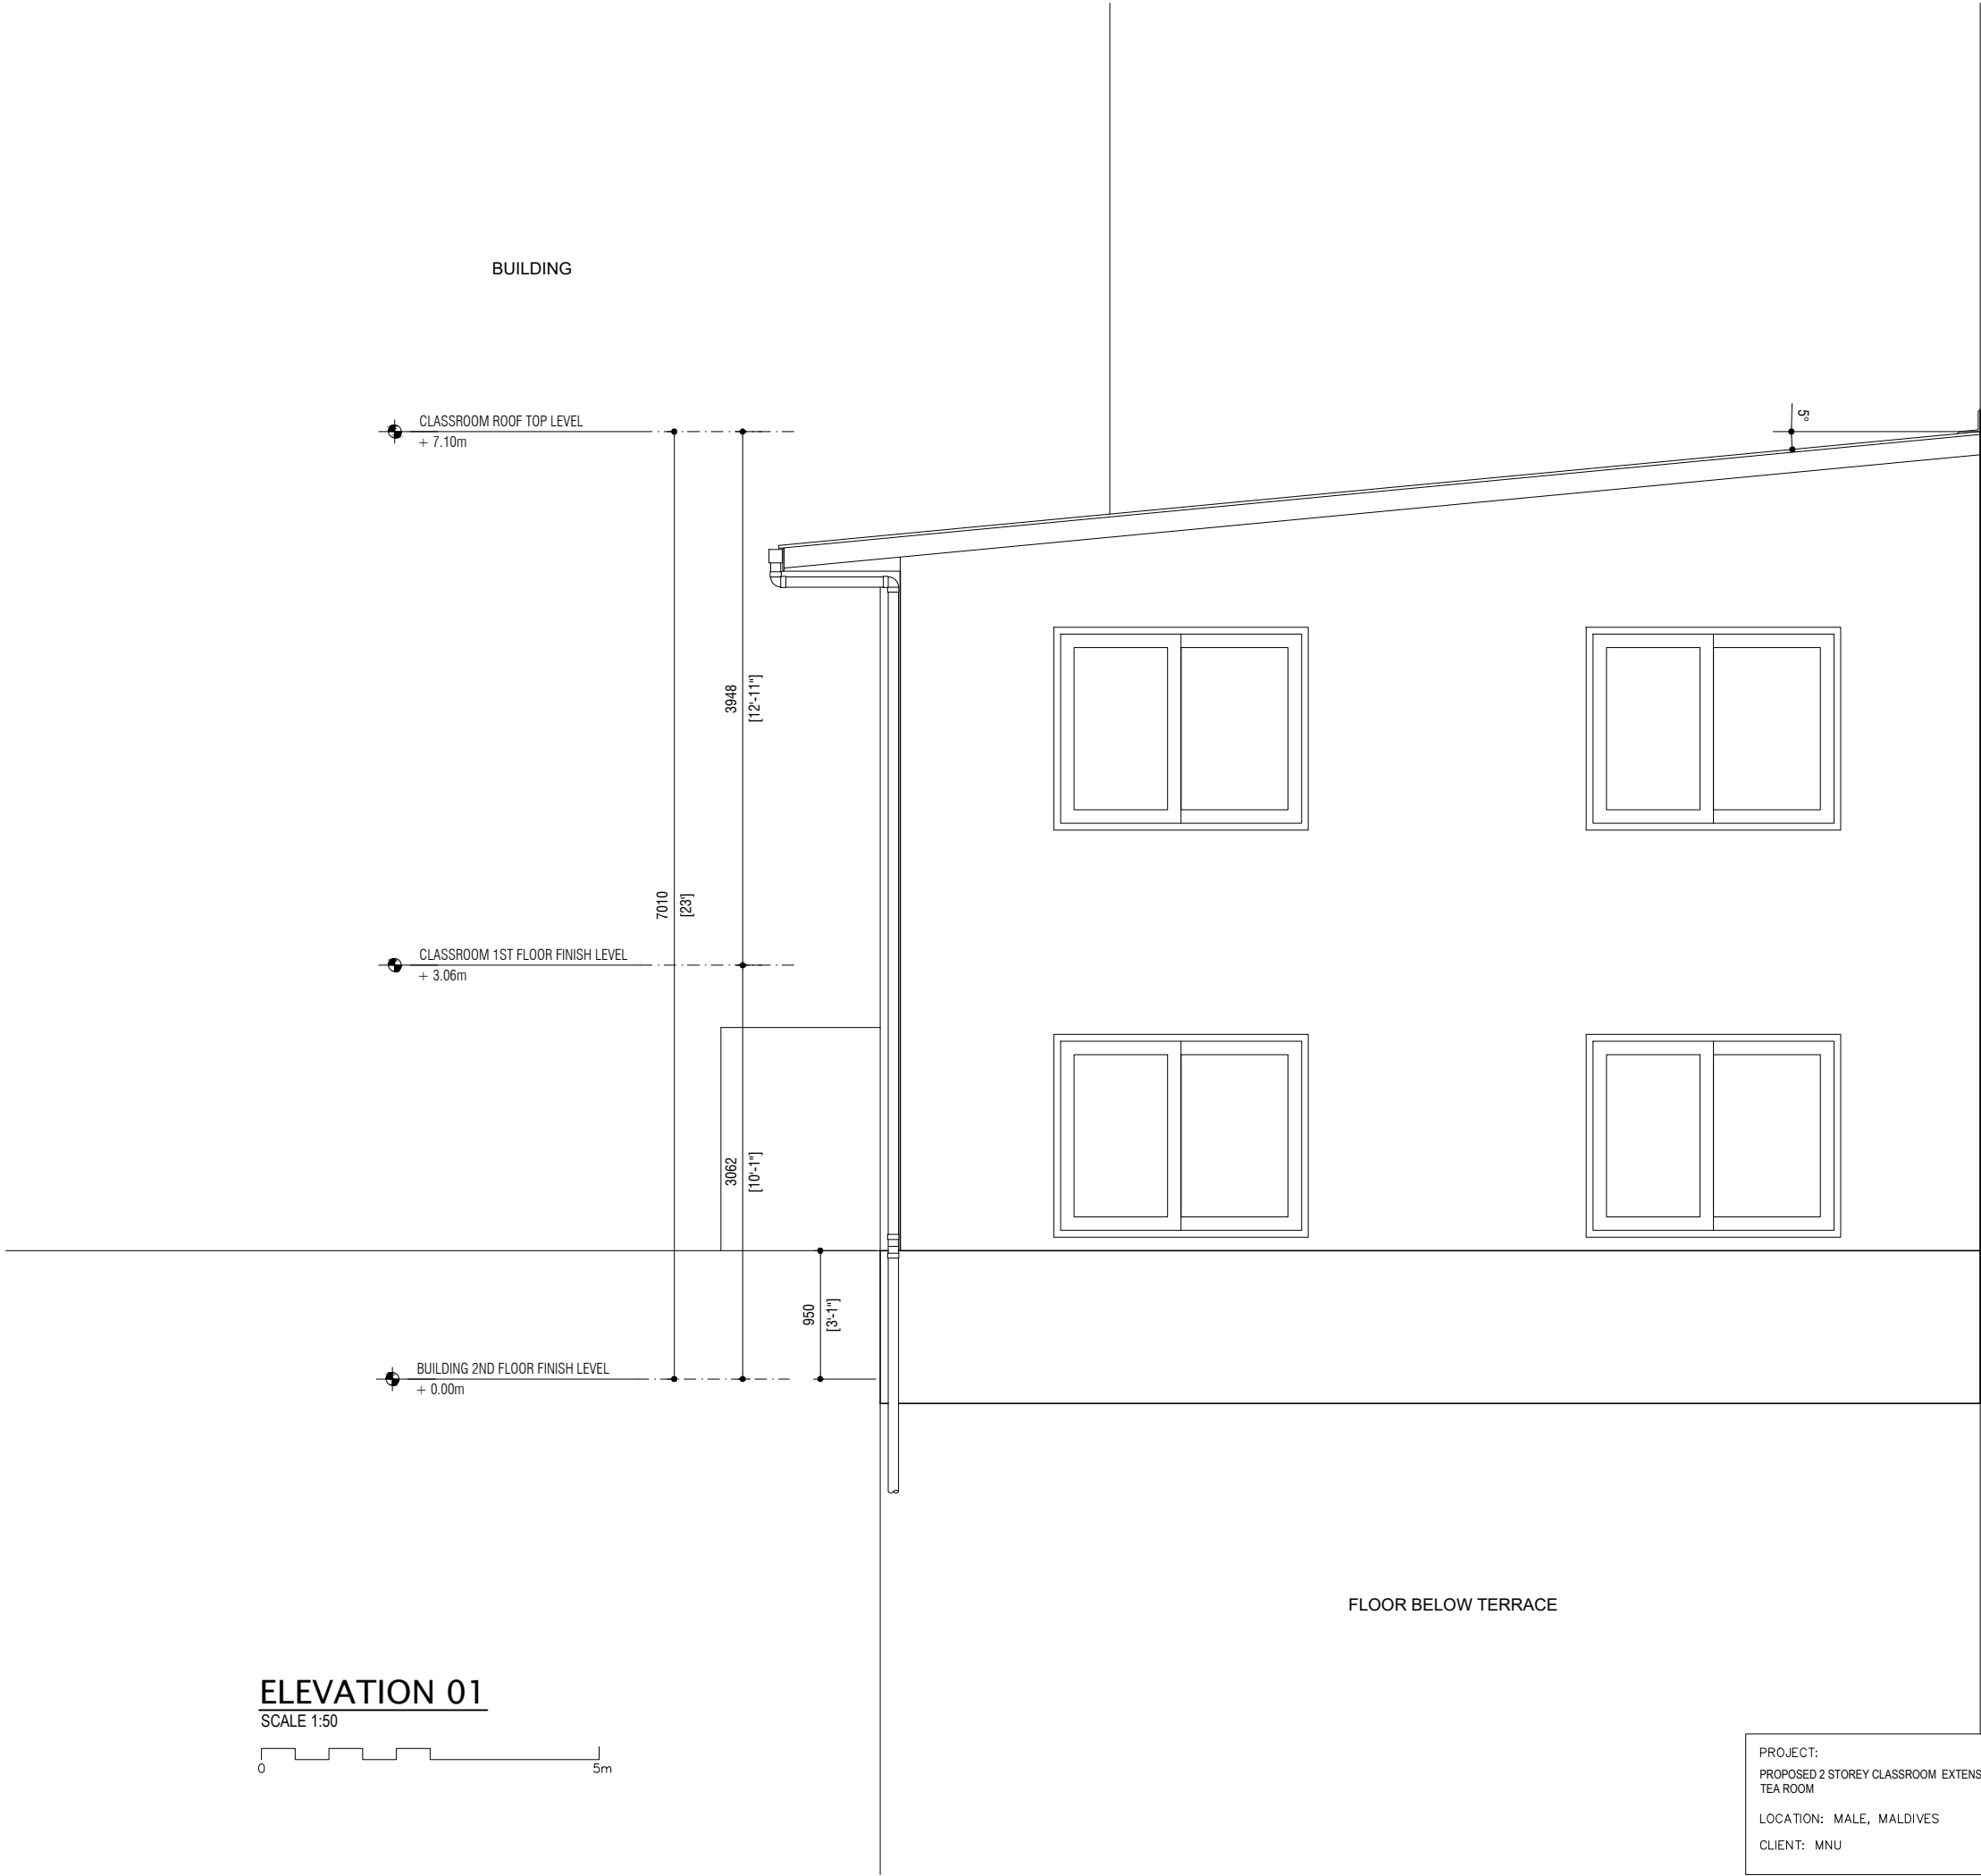

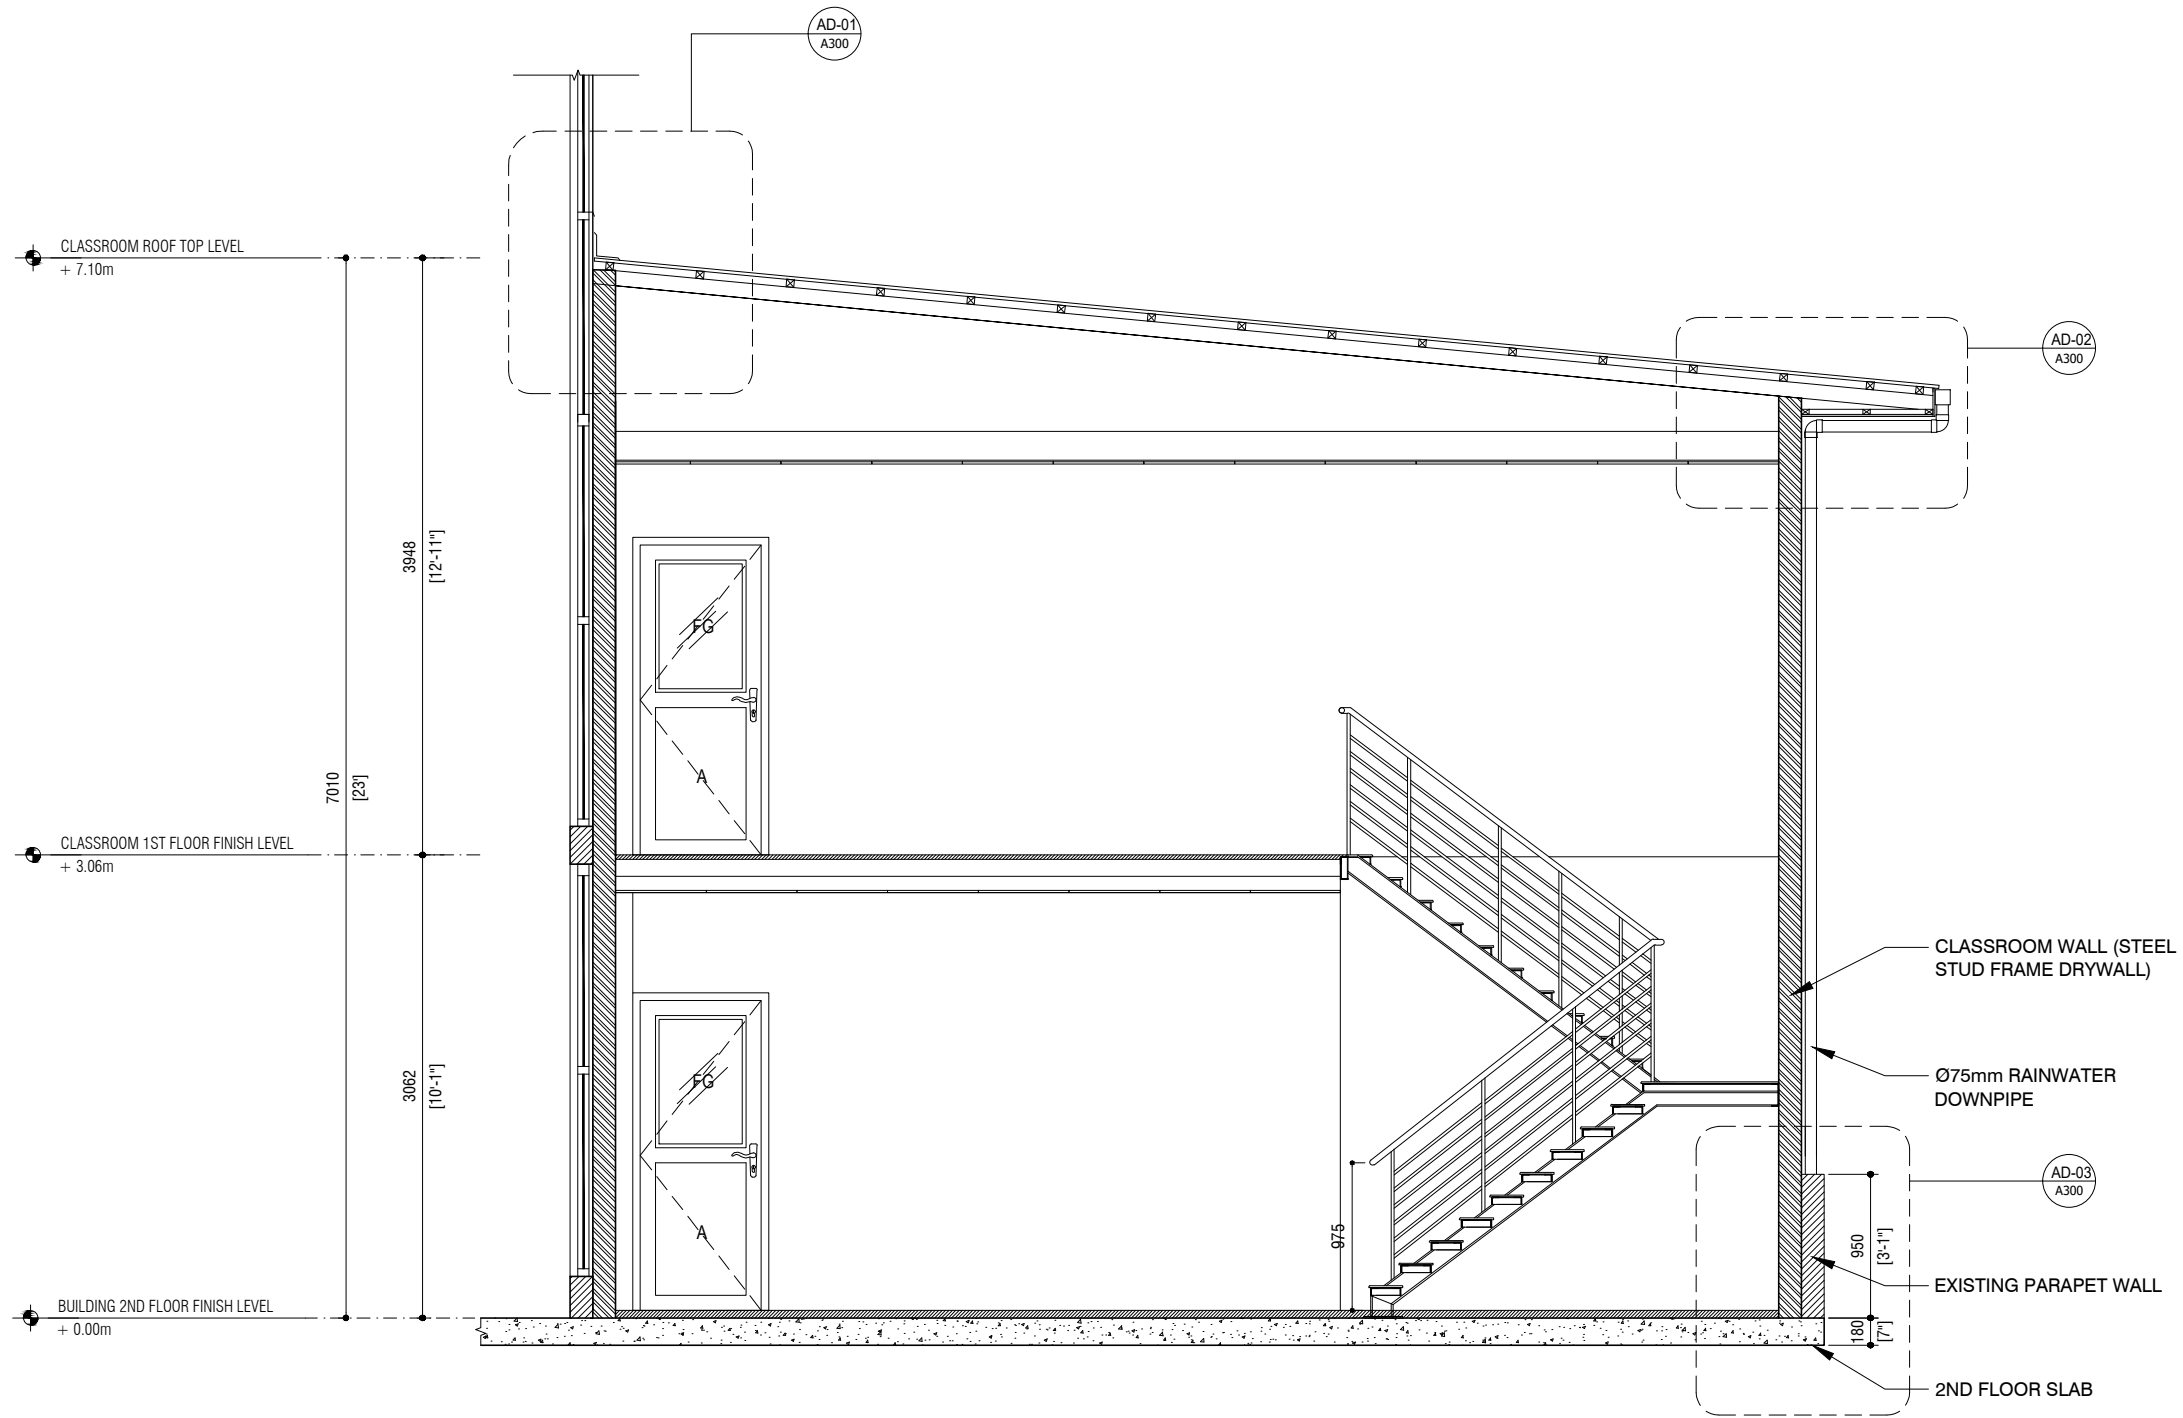


SECTION -X
SCALE 1:50

 

NOTE


STRUCTURAL DETAILS TO BE PROVIDED BY APPROVED CONSULTANT

PROJECT: PROPOSED 2 STOREY CLASSROOM EXTENSION & TEA ROOM LOCATION: MALE, MALDIVES CLIENT: MNU	DISCIPLINE: ARCHITECTURAL DRAWING TITLE: SECTION - X	PAPER SIZE SCALE DATE	A3 1:50 13 JUNE 2026
		SHEET NO: A204	

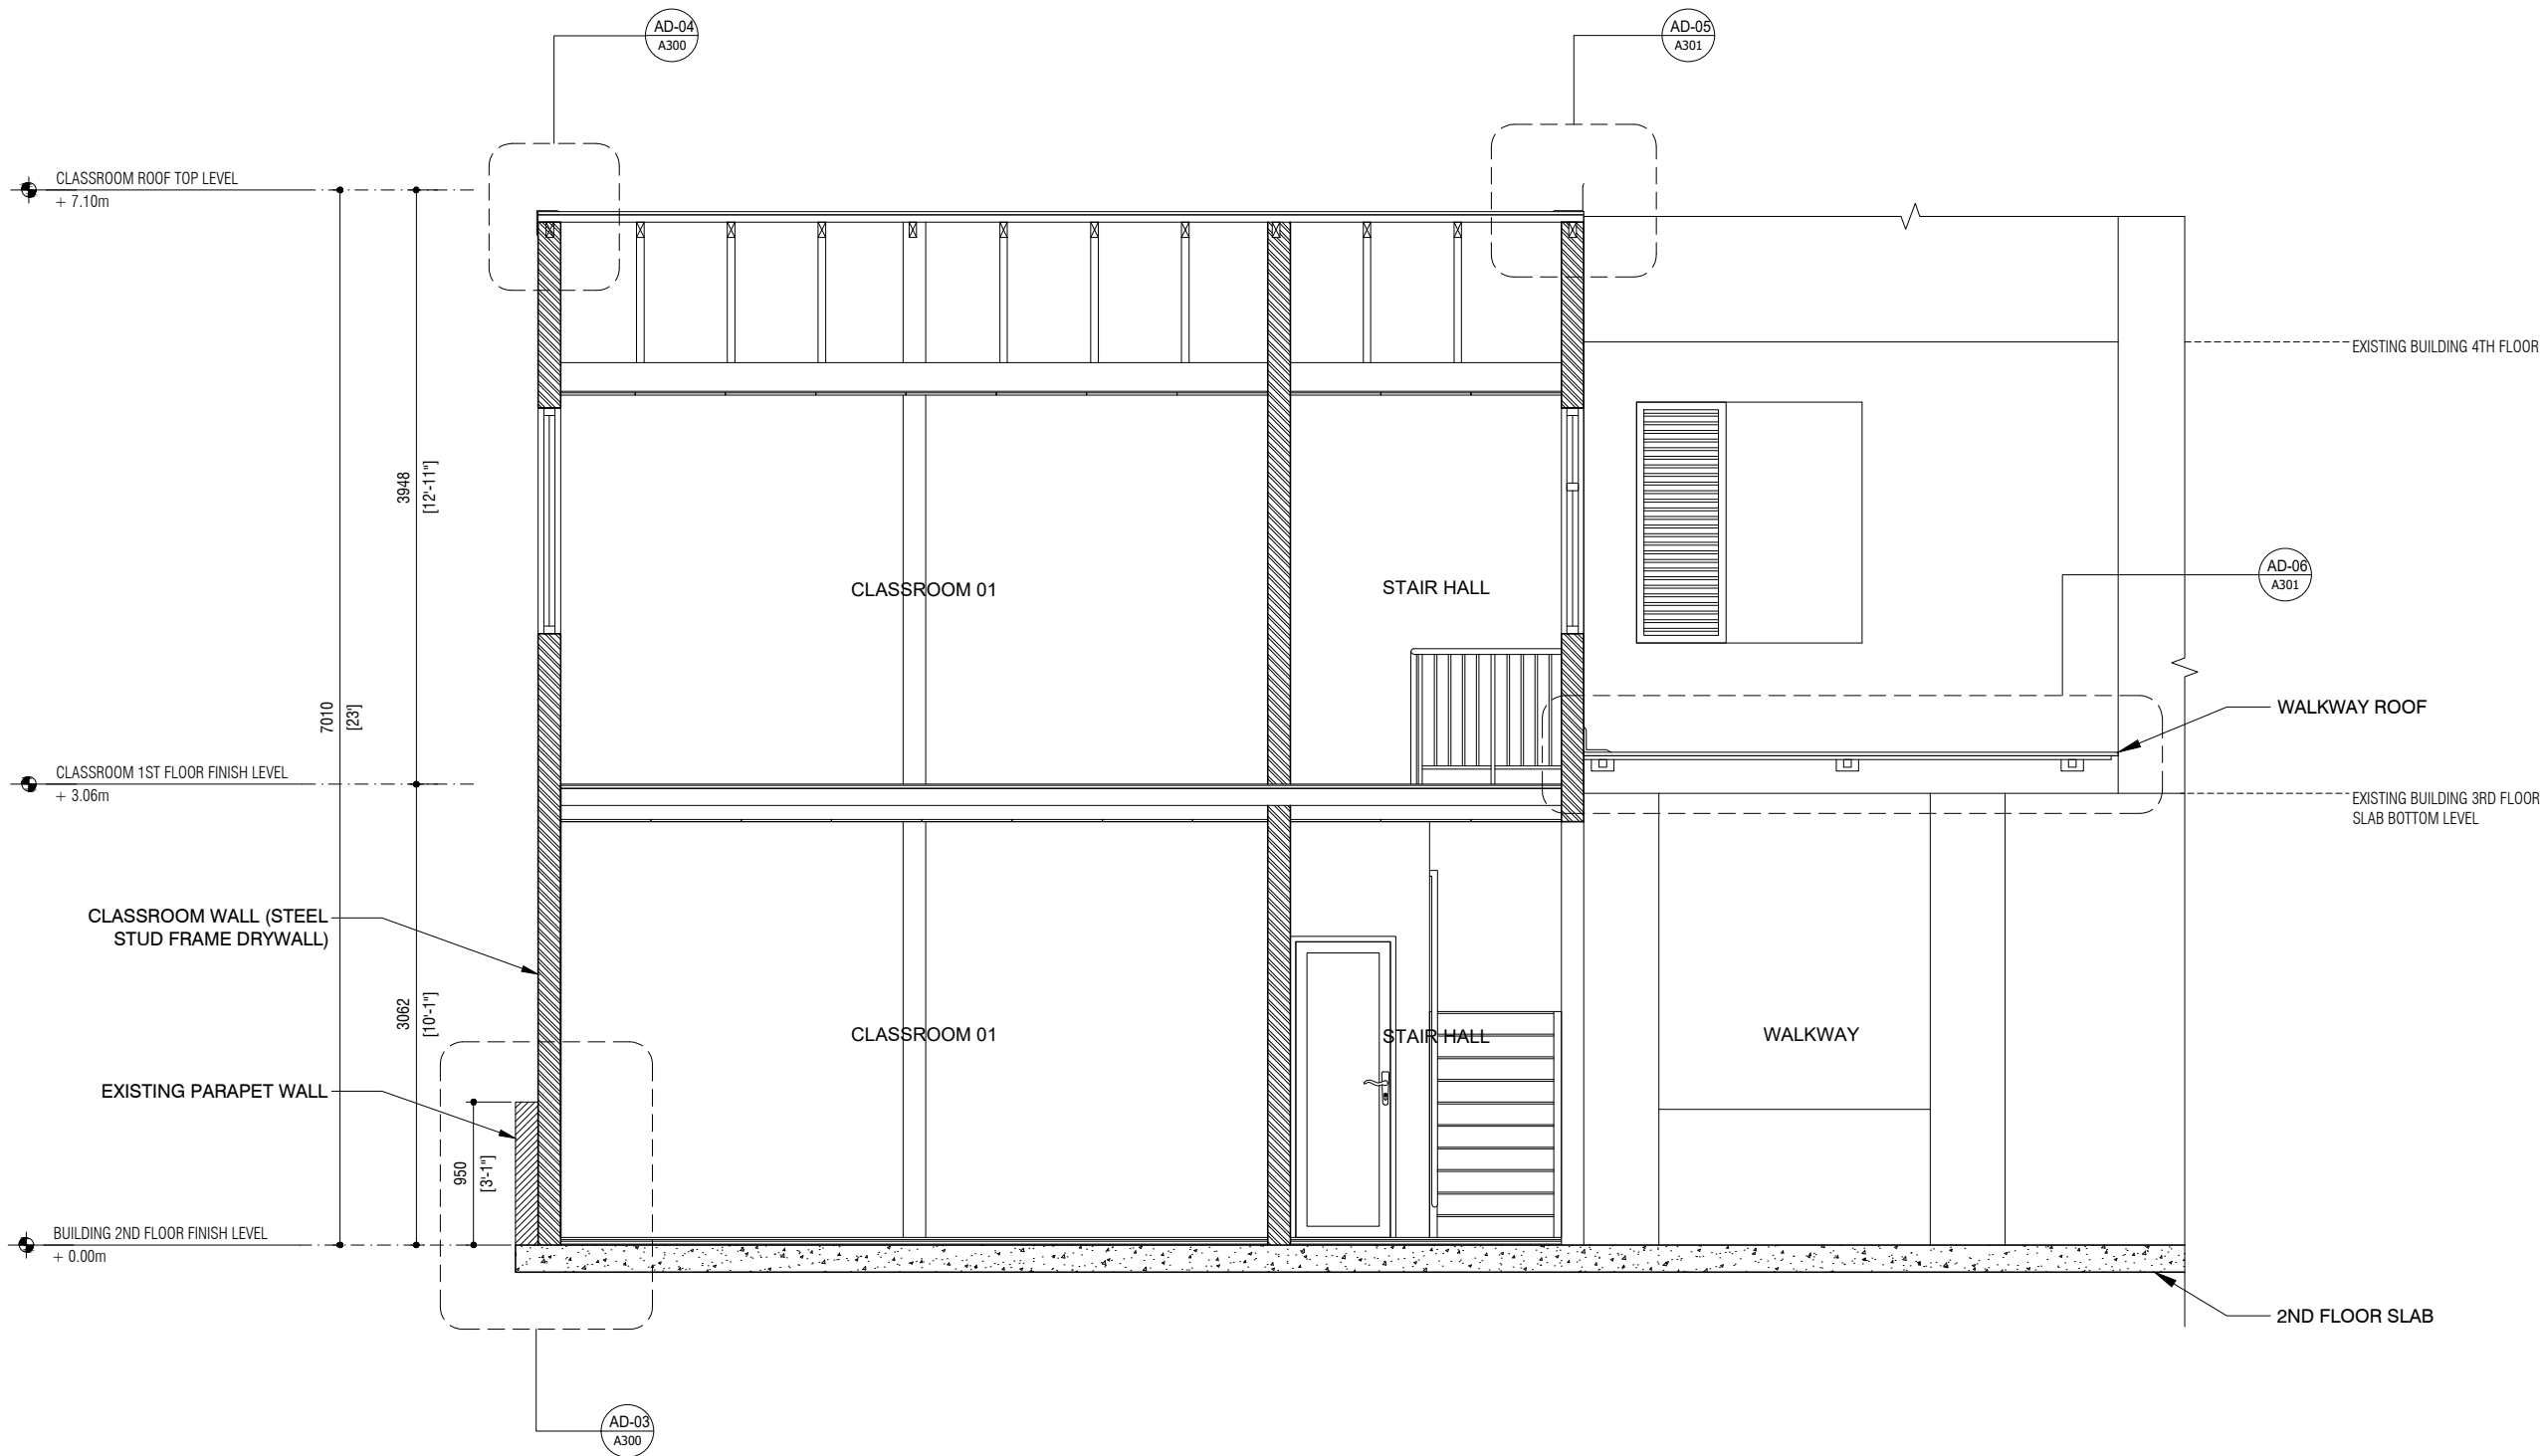

SECTION -Y

 SCALE 1:50



NOTE

STRUCTURAL DETAILS TO BE PROVIDED BY APPROVED CONSULTANT

PROJECT:
PROPOSED 2 STOREY CLASSROOM EXTENSION &
TEA ROOM
LOCATION: MALE, MALDIVES
CLIENT: MNU

DISCIPLINE:
ARCHITECTURAL
DRAWING TITLE:
SECTION - Y

PAPER SIZE
SCALE
DATE
A3
1:50
13 JUNE 2026

SHEET NO:
A205

SYMBOL	
OPENING AREA	1.64m ²
PLAN VIEW	
ELEVATION	
FLR. LVL.	
LOCATION	CLASSROOM 01 & CLASSROOM 02
QUANTITY	02
DOOR FRAME	POWDER COATED ALUM.
DOOR PANEL	PDR COARED ALUM WITH 6mm GLASS
LOCK/HINGES	LOCK X 1 , HINGES X 4
FINISHES	WHITE
REMARKS	1.8–2mm ALUM. SHEET

SYMBOL	
OPENING AREA	1.24m ²
PLAN VIEW	
ELEVATION	
FLR. LVL.	
LOCATION	CLASSROOM 01 & CLASSROOM 02
QUANTITY	08
DOOR FRAME	POWDER COATED ALUM.
DOOR PANEL	PDR COARED ALUM WITH 6mm GLASS
LOCK/HINGES	LOCK X 1
FINISHES	WHITE
REMARKS	–

SYMBOL	
OPENING AREA	0.00m ²
PLAN VIEW	
ELEVATION	
FLR. LVL.	
LOCATION	OUTSIDE CLASSROOM 02
QUANTITY	01
DOOR FRAME	POWDER COATED ALUM.
DOOR PANEL	6mm FIXED GLASS
LOCK/HINGES	–
FINISHES	WHITE
REMARKS	ALUMINUM LOUVERED

SYMBOL	
OPENING AREA	1.64m ²
PLAN VIEW	
ELEVATION	
FLR. LVL.	
LOCATION	STORE ROOM
QUANTITY	01
DOOR FRAME	POWDER COATED ALUM.
DOOR PANEL	PDR COARED ALUM WITH ALUM. SHEET
LOCK/HINGES	LOCK X 1 , HINGES X 4
FINISHES	WHITE
REMARKS	1.8–2mm ALUM. SHEET


NOTE:	
–	ALL MEASUREMENTS ARE IN MILLIMETER (MM)
–	ALL MEASUREMENTS TO BE CHECKED ON SITE PRIOR TO FABRICATION
–	RC LINTEL AND SILL BEAMS TO BE PROVIDED AT THE TOP AND BOTTOM (WHERE THE DOOR/ WINDOW OPENINGS DO NOT TOUCH THE FLOOR OR AN RC STRUCTURAL SURFACE)
–	ALL TEMPERED GLASS IN 6MM CLEAR
–	ALL TIMBER DOOR FRAMES IN SOLID WOOD, PUTTY SMOOTH SANDED.
–	DOOR SWING DIRECTIONS ARE AS PER PLANS.
T	-- TIMBER
G	-- GLASS
TG	-- TEMPERED GLASS
TL	-- TIMBER LOUVERED
GL	-- GLASS LOUVERED
A	-- ALUMINUM
AL	-- ALUMINUM LOUVERED
PVC	-- PLASTIC
WPC	-- WOOD PLASTIC COMPOSITE
S.S	-- STAINLESS STEEL
FB	-- FIBER BOARD
FRG	-- FROST GLASS
F.G	-- FIXED GLASS

DOOR/ WINDOW SCHEDULE 01

SCALE 1:50




PROJECT: PROPOSED 2 STOREY CLASSROOM EXTENSION & TEA ROOM	DISCIPLINE: ARCHITECTURAL	PAPER SIZE SCALE DATE	A3 1:50 13 JUNE 2026
LOCATION: MALE, MALDIVES CLIENT: MNU	DRAWING TITLE: DOOR WINDOW DETAILS - CLASSROOM BUILDING	SHEET NO: A206	

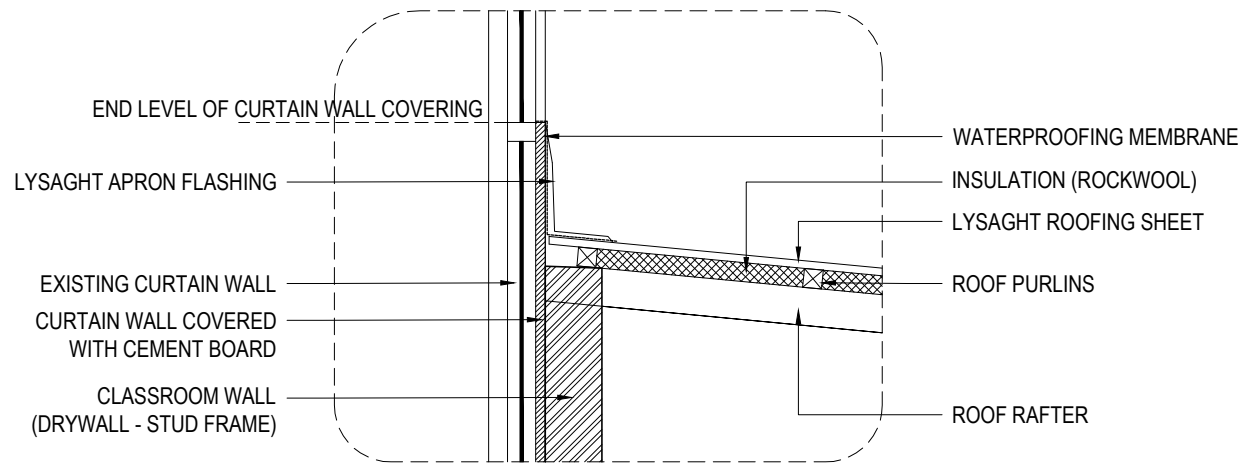


AD-01 - WALL ABUTMENT FLASHING DETAIL

SCALE 1:20

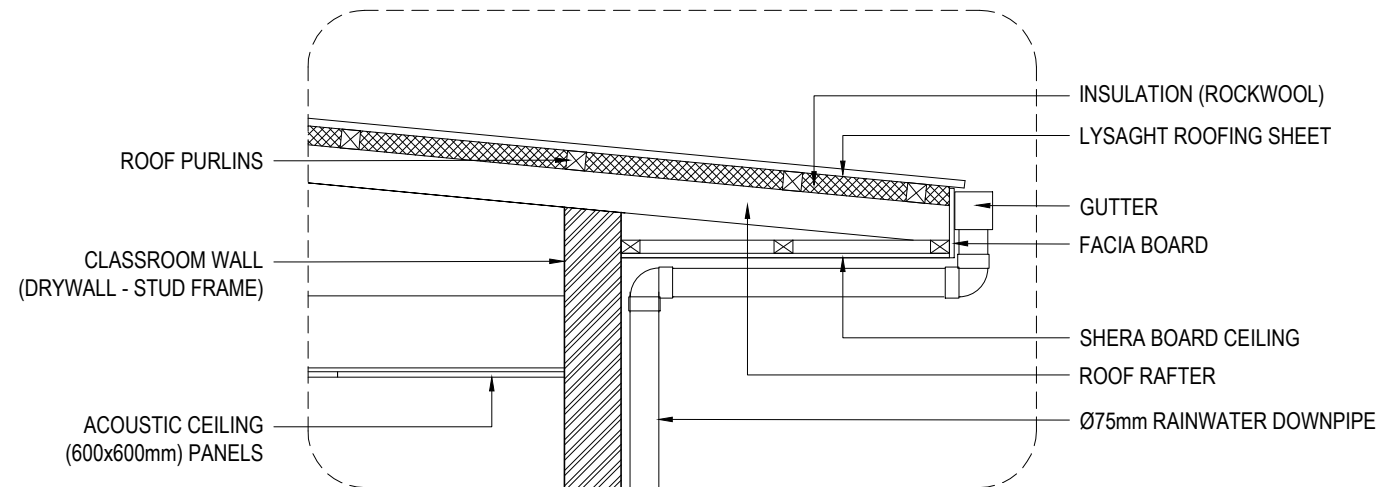

AD-02-ROOF EAVE DETAIL

SCALE 1:20

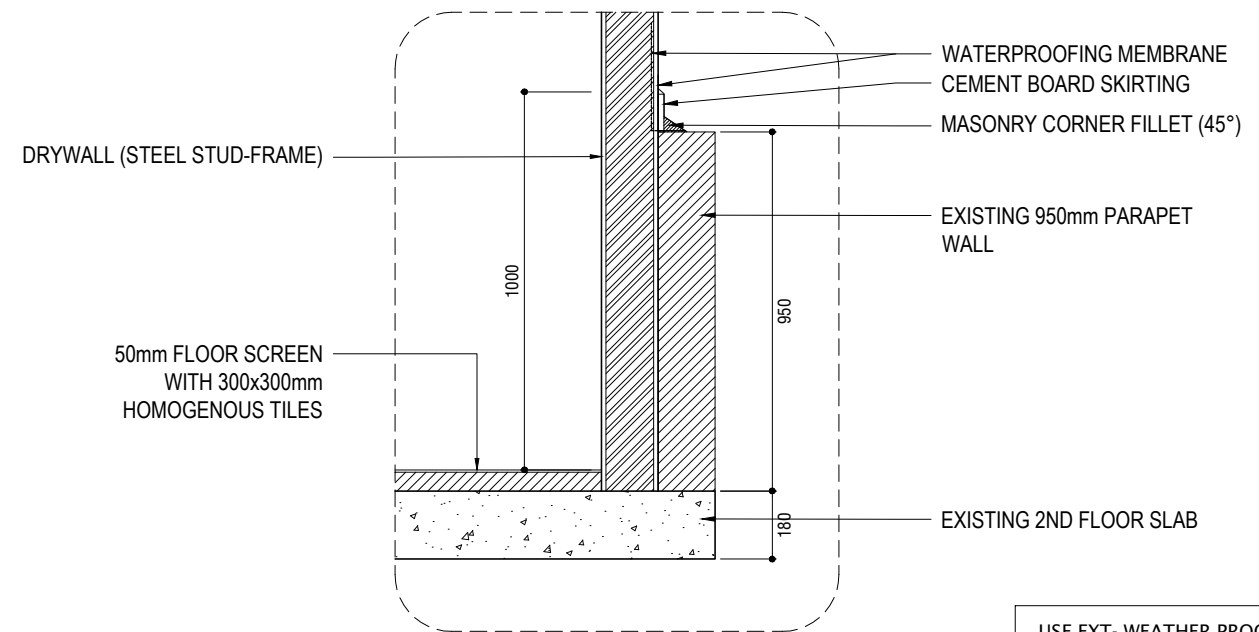


AD-03-WALL TO FLOOR DETAIL

SCALE 1:20

- APPLY WATER PROOFING PRIMER ON ALL EXTERIOR DRYWALL SURFACES
- APPLY FILLER/PUTTY TO ACHIEVE SMOOTH SURFACE ON ALL INTERIOR AND EXTERIOR DRY WALL SURFACES.
- SAND SMOOTH AND PAINT TO MATCH APPROVED EXISTING WALL COLOR.

USE EXT - WEATHER PROOF PAINT
(TO MATCH APPROVED COLOR OF
EXISTING BUILDING)
INT - WASHABLE PAINT (WHITE)

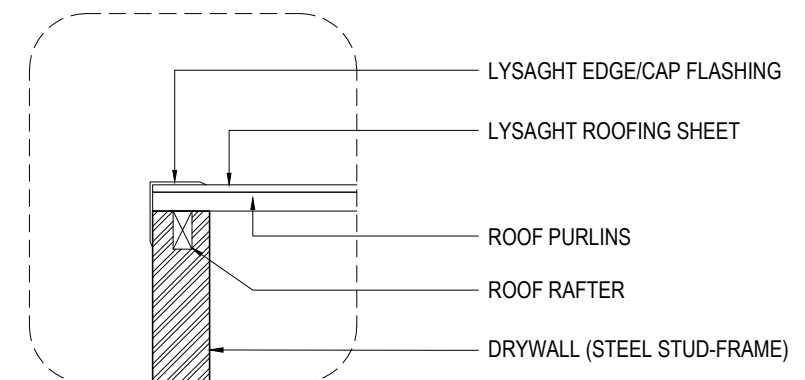


AD-04- EDGE FLASHING DETAIL

SCALE 1:20


ARCHITECTURAL DETAILS - 01

SCALE 1:20


PROJECT: PROPOSED 2 STOREY CLASSROOM EXTENSION & TEA ROOM LOCATION: MALE, MALDIVES CLIENT: MNU	DISCIPLINE: ARCHITECTURAL DRAWING TITLE: ARCHITECTURAL DETAILS 01	PAPER SIZE A3	SCALE 1:20
		DATE 13 JUNE 2026	SHEET NO: A300

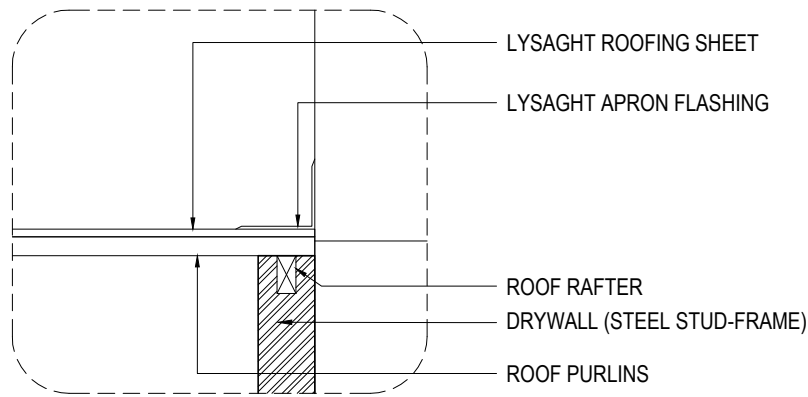

AD-05- APRON FLASHING DETAIL
SCALE 1:20

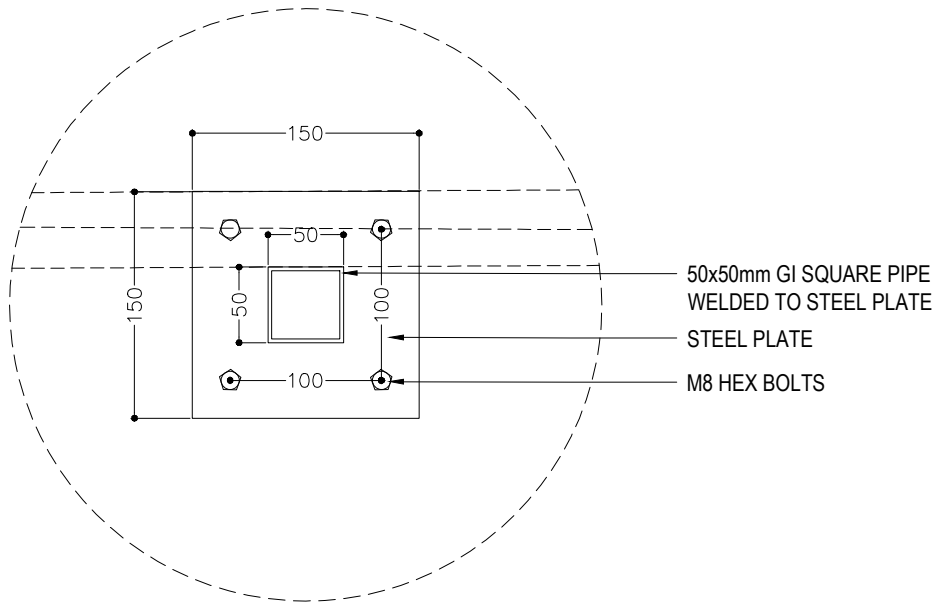


DETAIL - A
SCALE 1:5

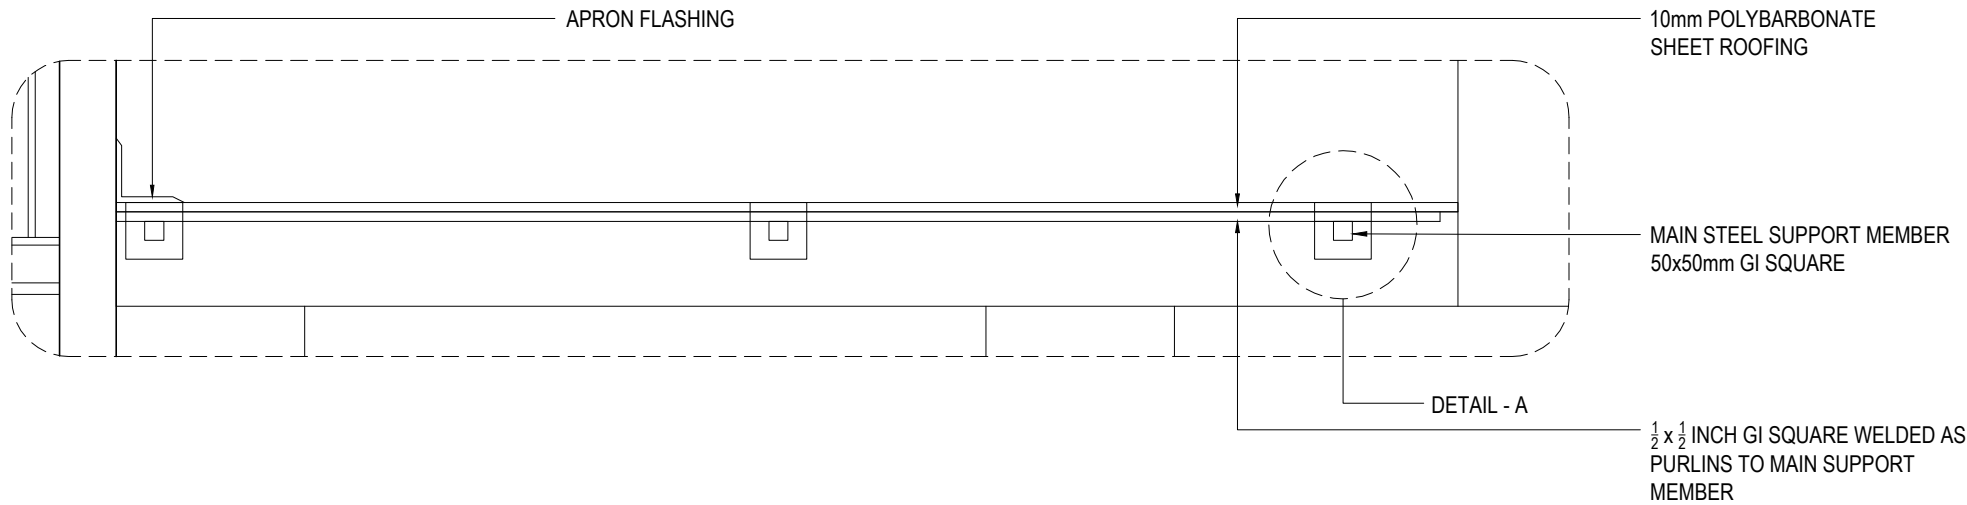

AD-06- WALKWAY ROOF DETAIL
SCALE 1:20

NOTE

- STEEL PLATE WELDED ON BOTH ENDS OF THE SUPPORT MEMBER AND FIXED TO THE ADJACENT WALL WITH M8 BOLTS.
- VERIFY DIMENSIONS ON SITE BEFORE FABRICATION.
- USE RUBBER SEAL SCREWS TO FIX POLYCARBONATE SHEET TO ROOF MEMBERS

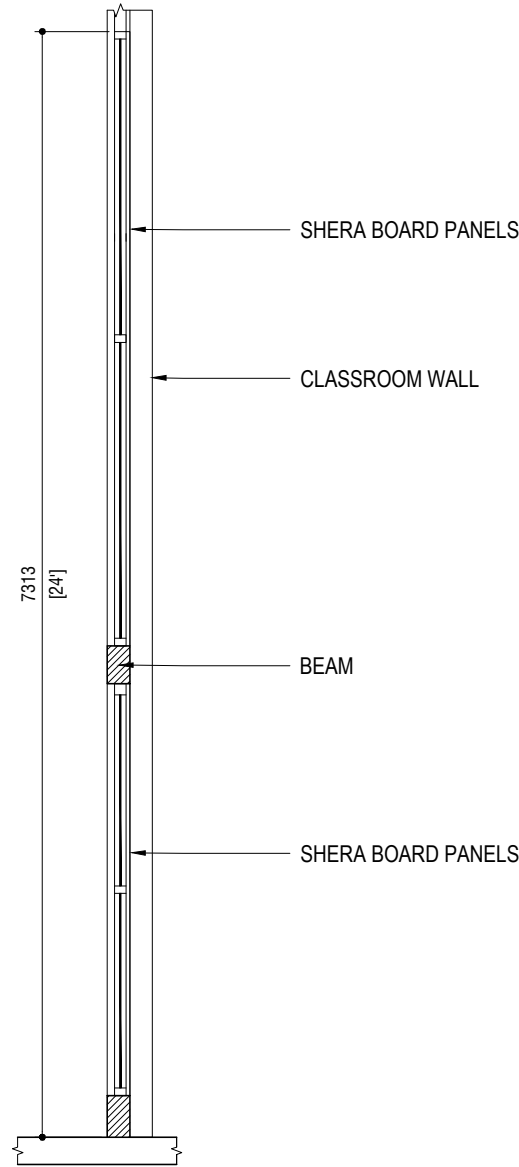


CURTAIN WALL COVERING DETAIL
SCALE 1:50

NOTE


- CURTAIN WALL SHALL BE COVERED UP TO THE BUILDING HEIGHT.
- **DO NOT** FIX DRY WALL DIRECTLY TO THE CURTAIN WALL FRAME.
- SEPARATE FRAME SHOULD BE USED TO FIX THE DRY WALL PANELS.
- USE 6-8mm SHERA BOARD PANELS.
- APPLY WATERPROOFING PRIMER ON EXTERIOR SURFACE AFTER PANEL INSTALLATION.
- PROVIDE SAME COVERING ON ALL WINDOWS AND VENTS OVERLAPPING WITH THE CLASSROOM WALL

ARCHITECTURAL DETAILS - 02
SCALE 1:20

PROJECT: PROPOSED 2 STOREY CLASSROOM EXTENSION & TEA ROOM LOCATION: MALE, MALDIVES CLIENT: MNU	DISCIPLINE: ARCHITECTURAL DRAWING TITLE: ARCHITECTURAL DETAILS 02	PAPER SIZE SCALE DATE	A3 1:20 13 JUNE 2026
		SHEET NO: A301	

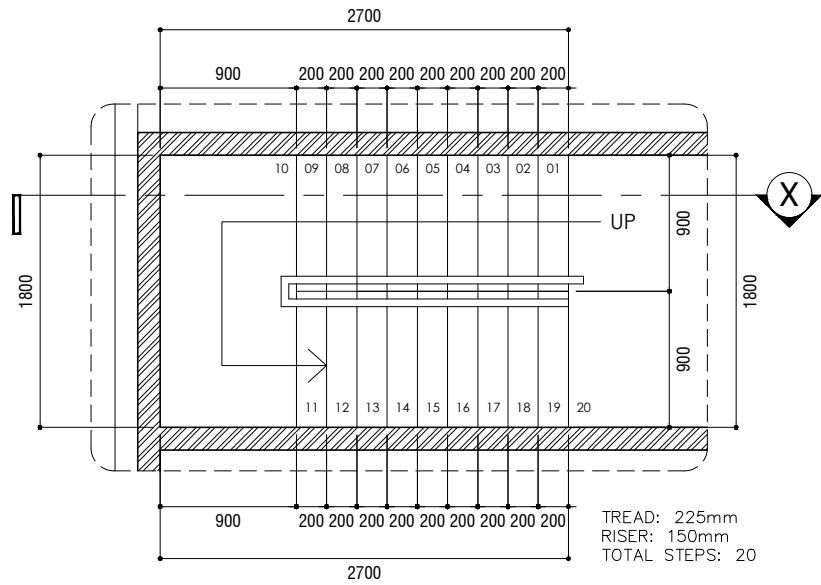


STAIR PLAN VIEW
SCALE 1:50

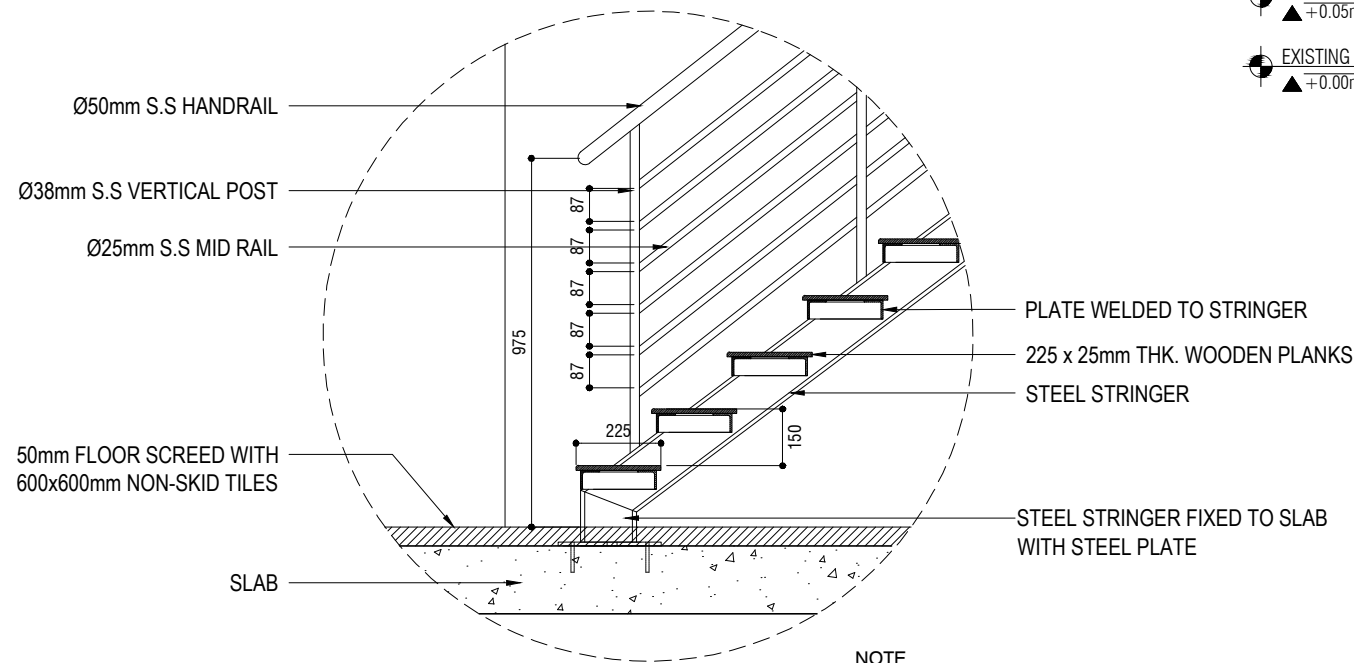

DETAIL - A
SCALE 1:20

- NOTE
- FOR HALF LANDING AREA USE SAME WIDTH WOODEN PLANKS.
 - USE HARDWOOD (RED MERANTI OR EQUIVALENT)
1. APPLY CLEAR/ TINTED WOOD GRAIN FILLER AFTER CUTTING AND SANDING THE BARE WOOD AND LET DRY. SCRAPE AND SAND SMOOTH AGAIN AFTER COMPLETELY DRY.
 2. FINAL TOP COAT WITH WATER-BASED POLY URETHANE (3-4 COATS)

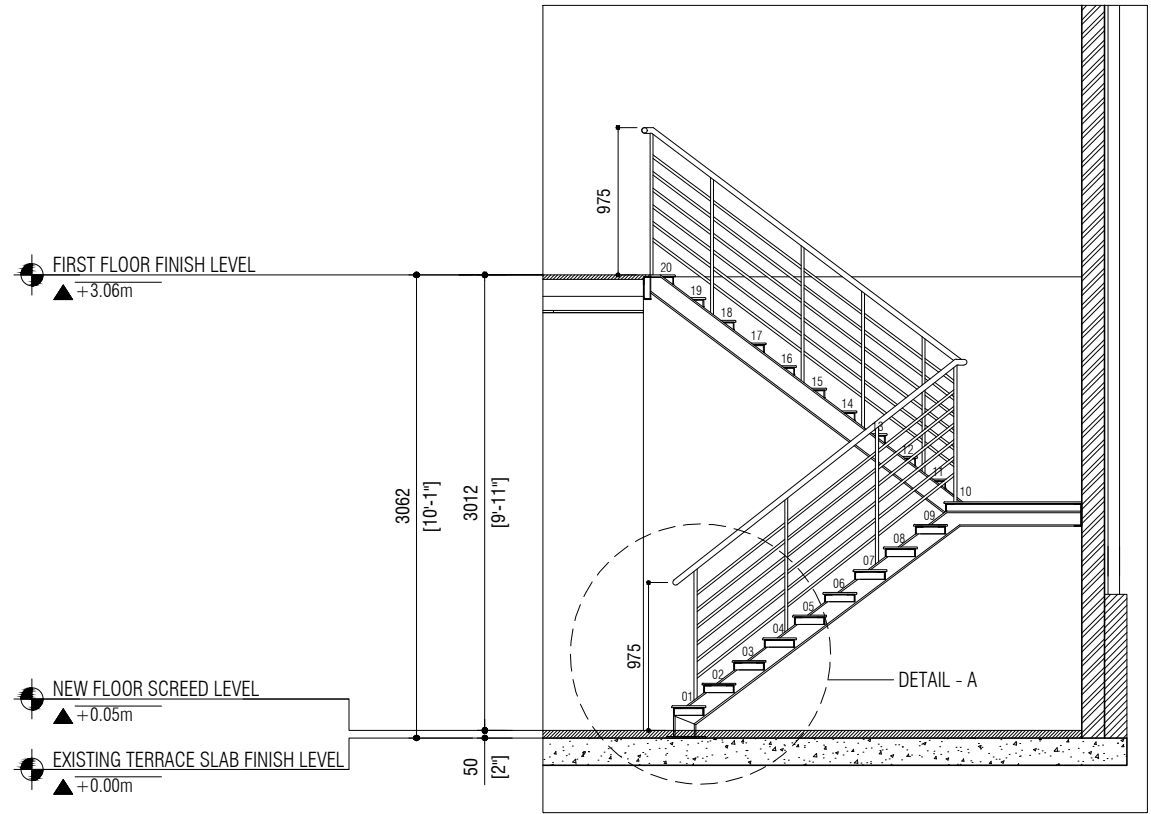


SECTION - X
SCALE 1:50

STRUCTURAL DETAILS TO BE PROVIDED BY APPROVED CONSULTANT


STAIR DETAILS

PROJECT: PROPOSED 2 STOREY CLASSROOM EXTENSION & TEA ROOM	DISCIPLINE: ARCHITECTURAL	PAPER SIZE SCALE DATE	A3 AS GIVEN 13 JUNE 2026
LOCATION: MALE, MALDIVES CLIENT: MNU	DRAWING TITLE: STAIR DETAILS	SHEET NO: A302	

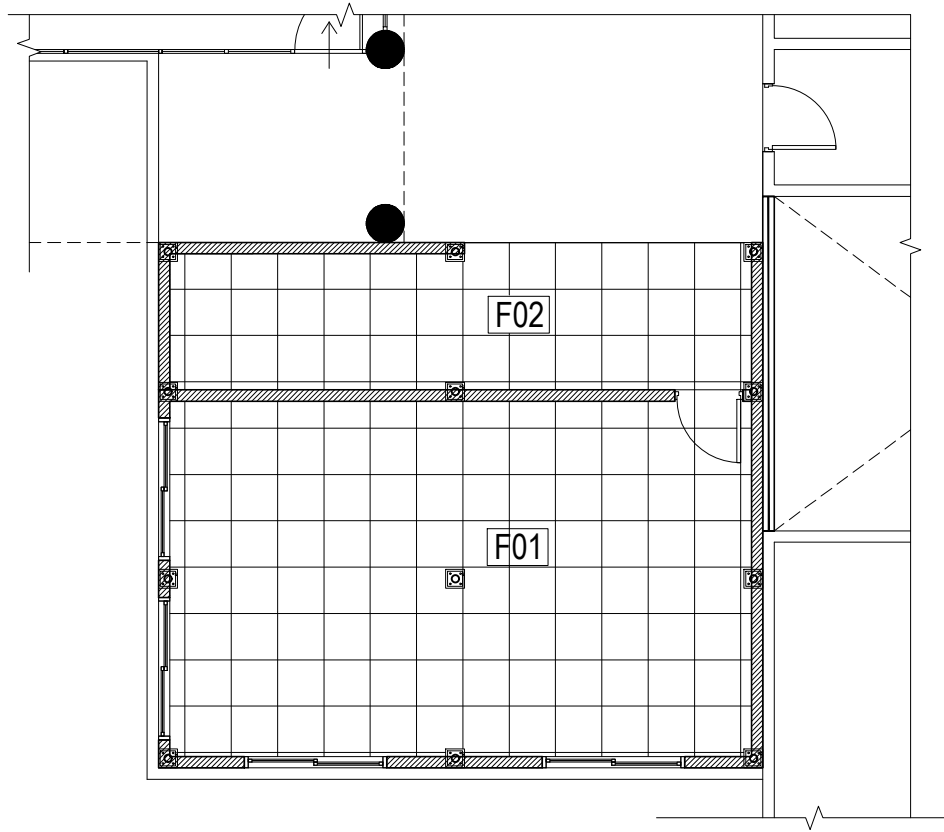


CLASSROOM LEVEL 01 FLOOR FINISH

 SCALE 1:100




F01

 


600x600mm HOMOGENOUS FLOOR
TILES
COLOR: WHITE

 F02




600x600mm HOMOGENOUS FLOOR
TILES - NON SKID
COLOR: WHITE

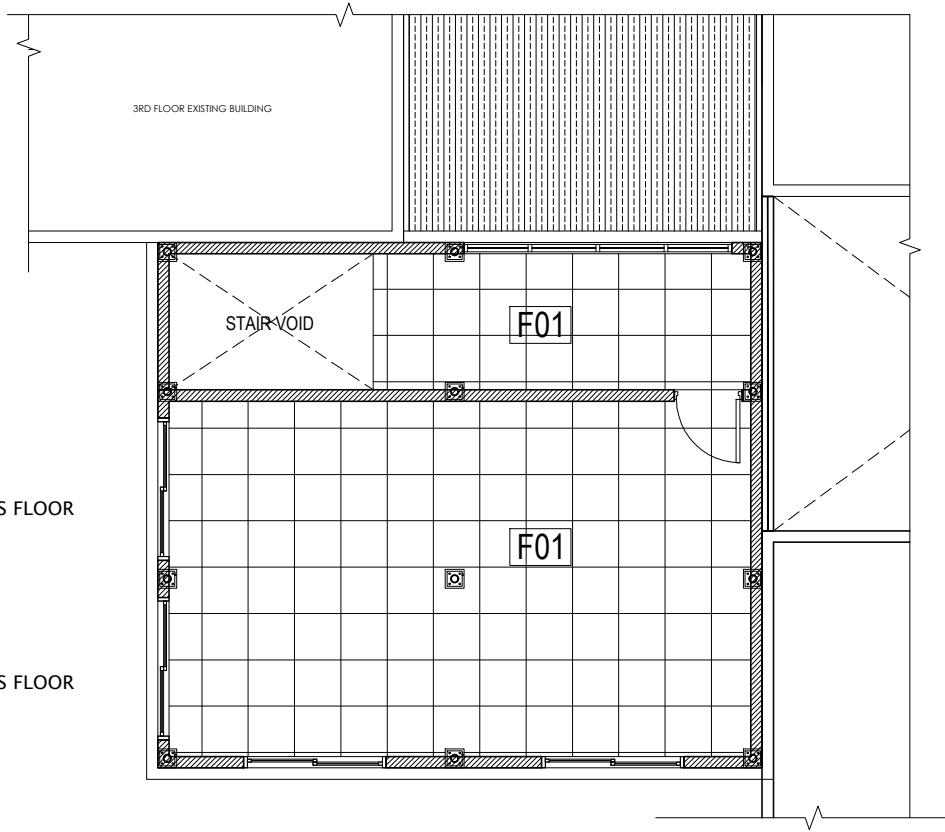

CLASSROOM LEVEL 02 FLOOR FINISH

 SCALE 1:100



PROJECT:
PROPOSED 2 STOREY CLASSROOM EXTENSION &
TEA ROOM


LOCATION: MALE, MALDIVES
CLIENT: MNU

DISCIPLINE:
ARCHITECTURAL

DRAWING TITLE:
FLOOR FINISH LAYOUT CLASSROOM 01 & 02


PAPER SIZE
SCALE
DATE

SHEET NO:
A400

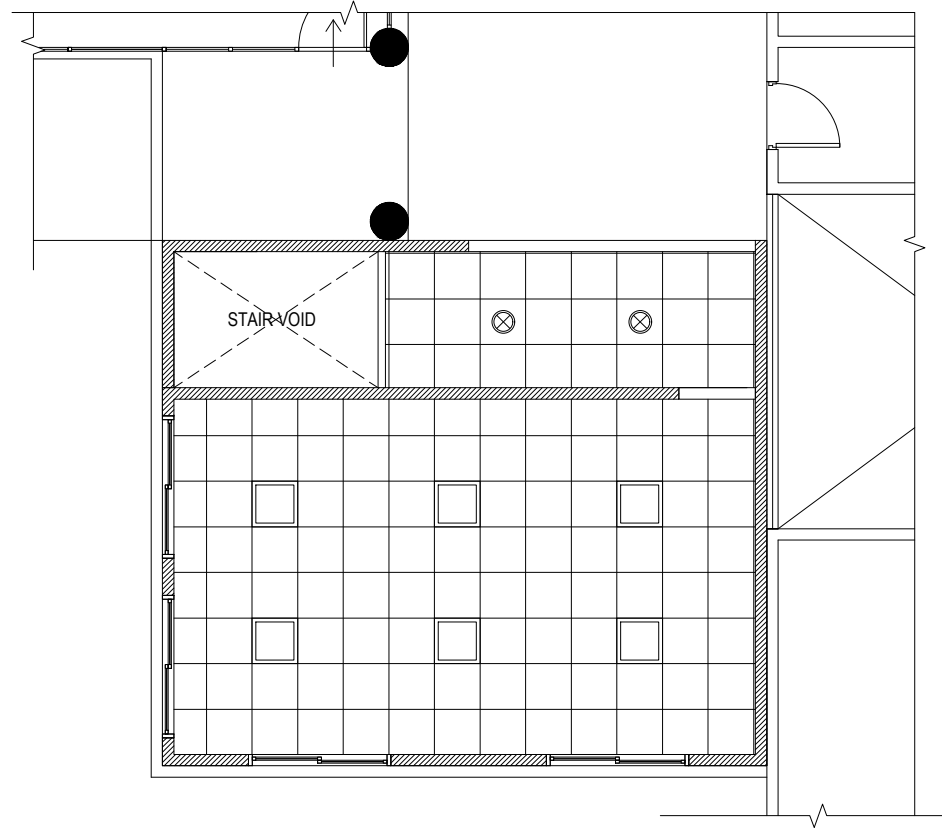


REFLECTED CEILING LAYOUT - LEVEL 01

SCALE 1:100

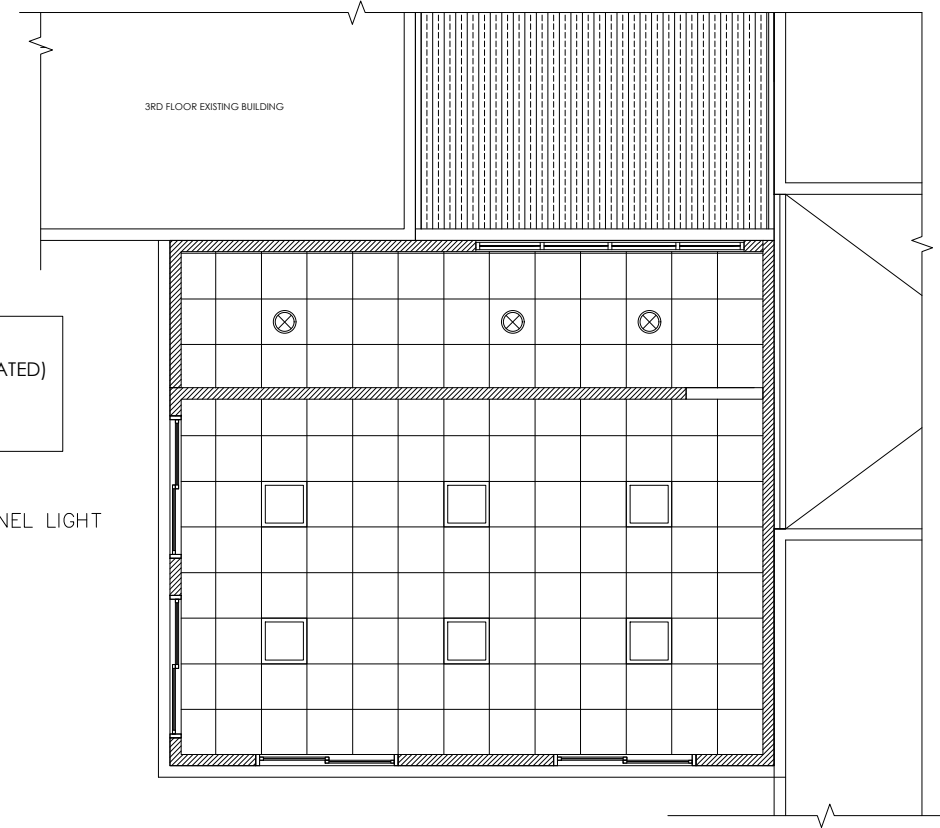

REFLECTED CEILING LAYOUT - LEVEL 02

SCALE 1:100

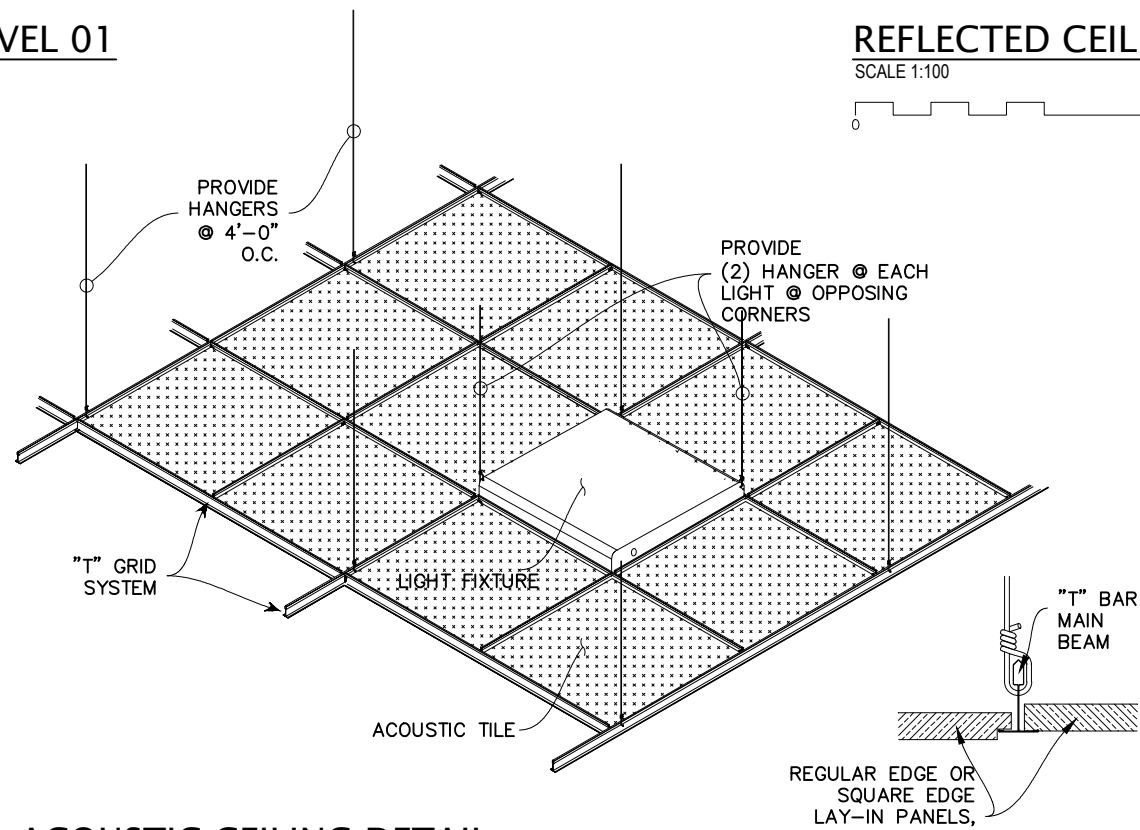


ACOUSTIC CEILING DETAIL


NTS

PROJECT: PROPOSED 2 STOREY CLASSROOM EXTENSION & TEA ROOM LOCATION: MALE, MALDIVES CLIENT: MNU	DISCIPLINE: ARCHITECTURAL	PAPER SIZE SCALE DATE	A3 AS GIVEN 13 JUNE 2026
	DRAWING TITLE: REFLECTED CEILING LAYOUT	SHEET NO: A401	

MEP DRAWINGS
CLASSROOM BUILDING
13 JUNE 2026

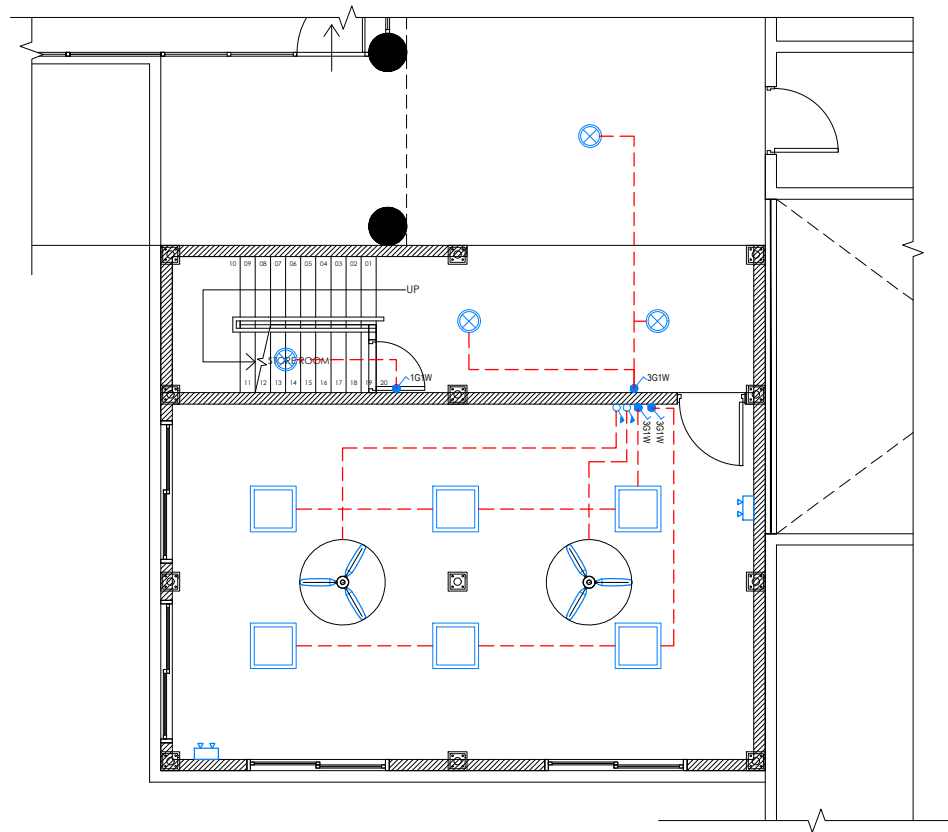


CLASSROOM - LEVEL 01 ELECTRICAL LAYOUT
SCALE 1:100

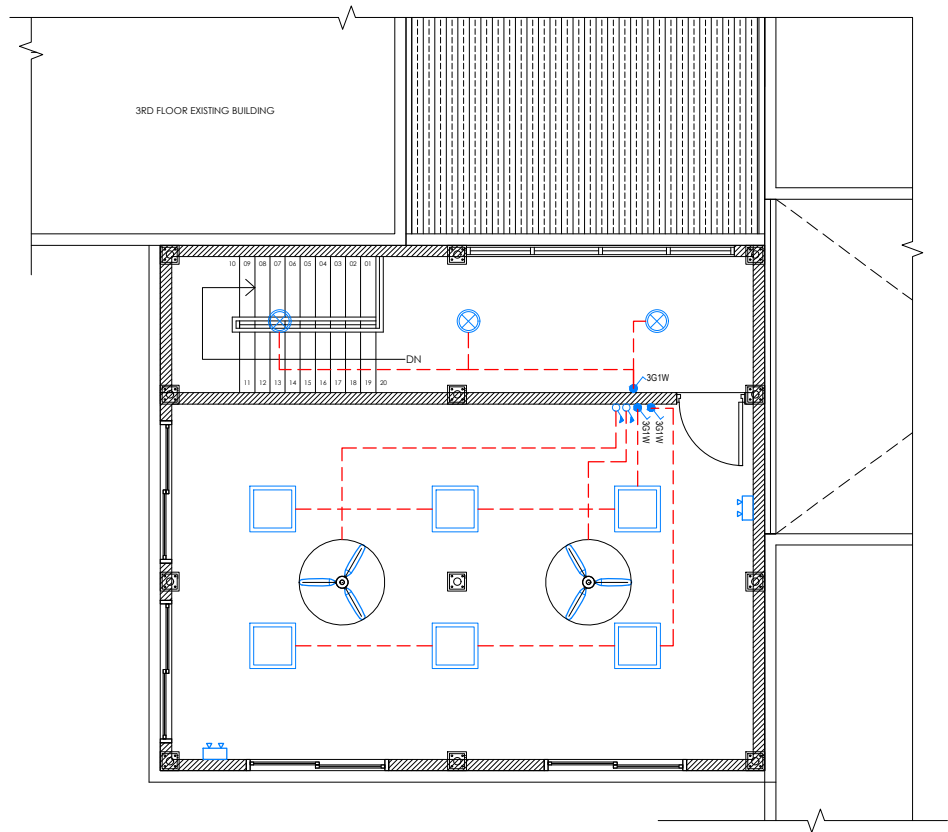


CLASSROOM - LEVEL 02 ELECTRICAL LAYOUT
SCALE 1:100

SYMBOL	DESCRIPTION
	600x600MM LED RECESSED CEILING LIGHT PANEL
	18w CEILING MOUNT LED LIGHT
	CEILING FAN - 48 INCH DIA.
	EMERGENCY LIGHT
	FAN REGULATOR
	LIGHT SWITCH
	ELECTRICAL WIRING

PROJECT: PROPOSED 2 STOREY CLASSROOM EXTENSION & TEA ROOM LOCATION: MALE, MALDIVES CLIENT: MNU	DISCIPLINE: ARCHITECTURAL DRAWING TITLE: CLASSROOM LEVEL 01 & 02 - ELECTRICAL LAYOUT	PAPER SIZE SCALE DATE	A3 1:100 13 JUNE 2026
		SHEET NO: M100	

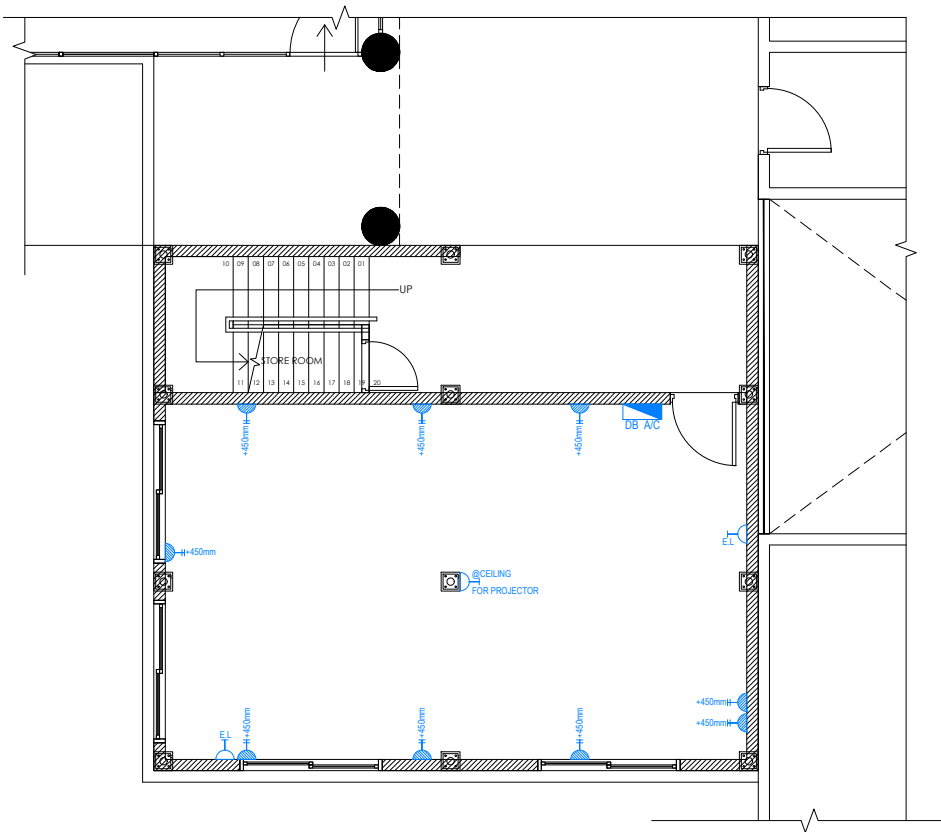


CLASSROOM - LEVEL 01 POWER LAYOUT
SCALE 1:100

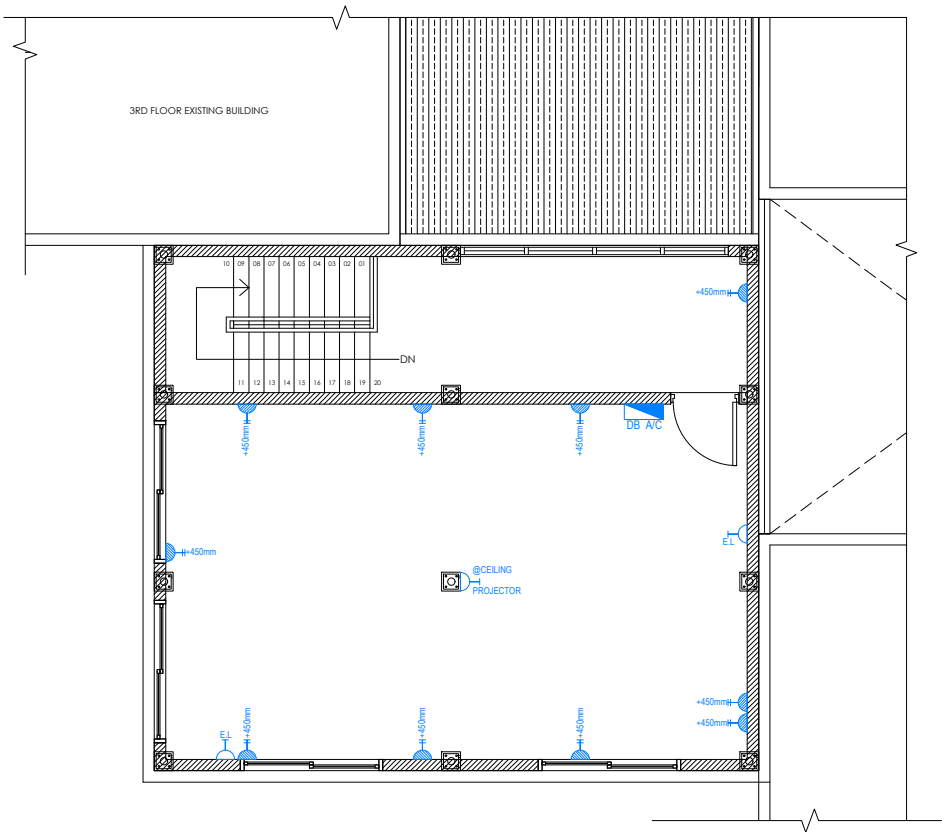


CLASSROOM - LEVEL 02 POWER LAYOUT
SCALE 1:100

SYMBOL	DESCRIPTION
	DISTRIBUTION BOARD
	SINGLE SOCKET
	DOUBLE SOCKET
	SINGLE SOCKET @HIGH LEVEL

PROJECT: PROPOSED 2 STOREY CLASSROOM EXTENSION & TEA ROOM LOCATION: MALE, MALDIVES CLIENT: MNU	DISCIPLINE: ARCHITECTURAL DRAWING TITLE: CLASSROOM LEVEL 01 & 02 - POWER LAYOUT	PAPER SIZE SCALE DATE	A3 1:100 13 JUNE 2026
		SHEET NO: M101	

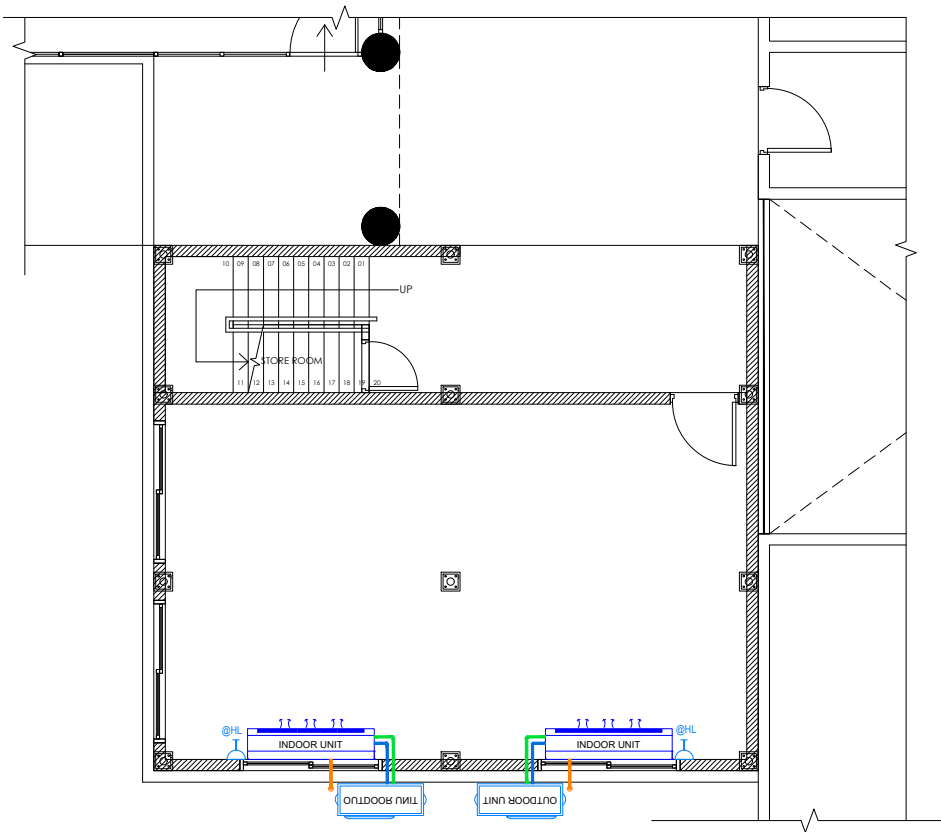

CLASSROOM - LEVEL 01 AC LAYOUT
SCALE 1:100

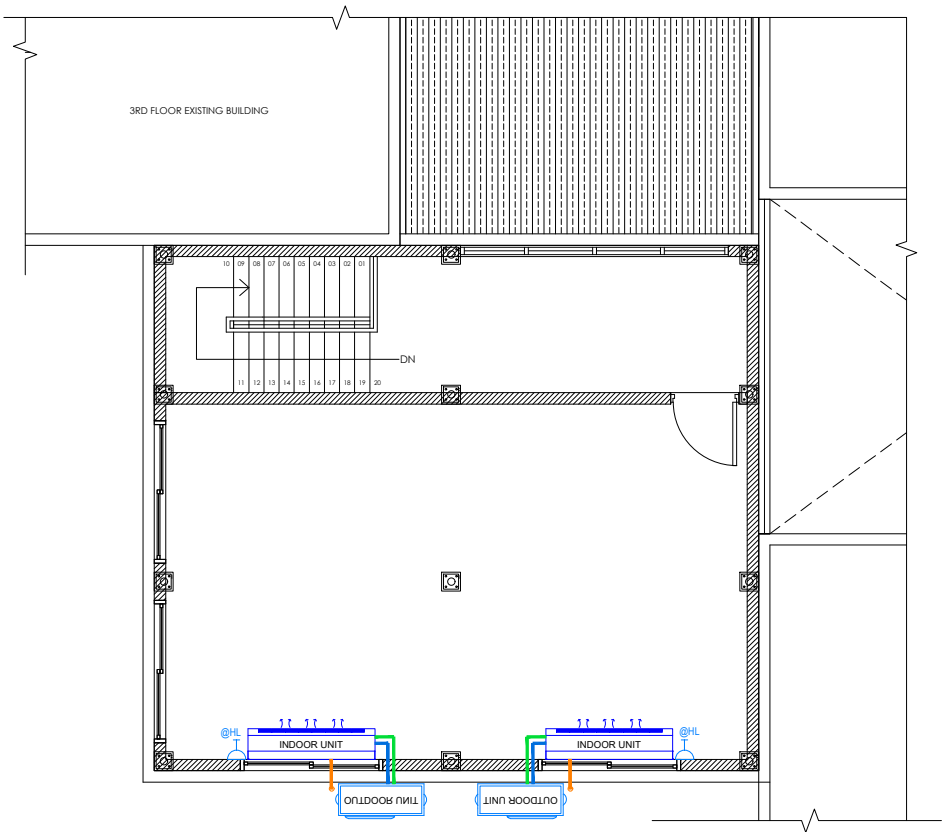

CLASSROOM - LEVEL 02 AC LAYOUT
SCALE 1:100

SYMBOL	DESCRIPTION
	INSULATED LIQUID PIPE
	INSULATED GAS PIPE
	DRAINAGE LINE
	FAN COIL UNIT
	CONDENSER UNIT
	SINGLE SOCKET OUTLET - 16A

PROJECT: PROPOSED 2 STOREY CLASSROOM EXTENSION & TEA ROOM LOCATION: MALE, MALDIVES CLIENT: MNU	DISCIPLINE: ARCHITECTURAL DRAWING TITLE: CLASSROOM LEVEL 01 & 02 - AC LAYOUT	PAPER SIZE SCALE DATE	A3 1:50 13 JUNE 2026
		SHEET NO: M102	