


ELECTRICAL LAYOUT

SCALE: 1 : 100

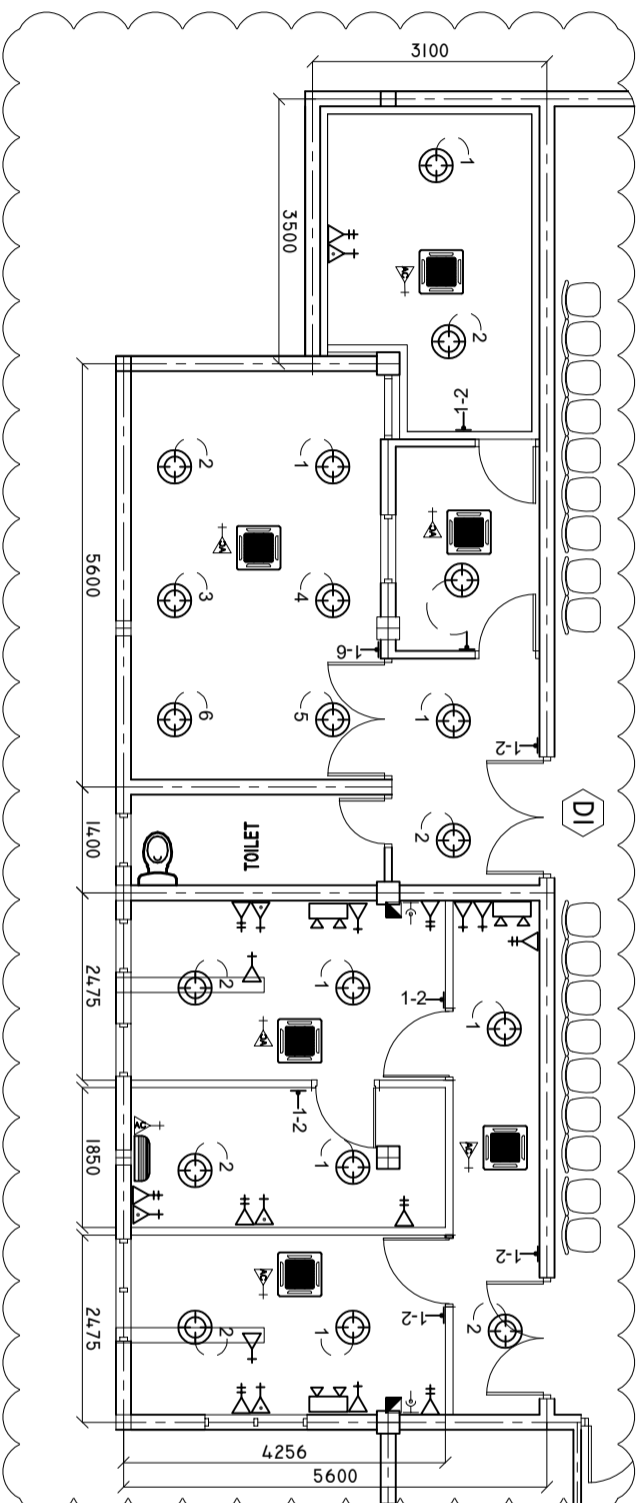

LEGEND

SYMBOL	DESCRIPTION
	LED BULB WITH 150MM DOWN LIGHT
	1 x 13 AMP SOCKET OUTLET (FLOOR MOUNT)
	2 x 13 AMP SOCKET OUTLET (600MM ABOVE FFL)
	1 x 15 AMP SOCKET OUTLET (600MM ABOVE FFL)
	1 x 15 AMP AC SOCKET OUTLET (300MM BLW, CEILING)
	TWO GANG SWITCH
	ONE WAY SWITCH
	EMERGENCY LIGHT
	DISTRIBUTION BOARD (WALL EMBEDDED)
	TELEPHONE SOCKET
	NETWORK SOCKET
	1 x 13 AMP SOCKET OUTLET (200MM BELOW CEILING)
	AC OUTDOOR UNIT
	AC INDOOR UNIT, CEILING CASSETTE TYPE
	EARTH PIT
	AC WALL MOUNT UNIT

SHEET CONTENTS :

REVISION NOTES:

PROJECT:
 RENOVATION OF
 RADIOLOGY
 DEPARTMENT AT R.
 UGOOFAARU REGIONAL
 HOSPITAL

CLIENT:
 MINISTRY OF HEALTH

LOCATION:
 R . UGOOFAARU

CONTENTS: AS GIVEN

PROJECT MANAGER:

DESIGNER: ARIZ

CV/STR. ENGINEER:

SURVEYED BY: -

DRAWN BY: ARIZ

CHECKED BY:

DATE : FEBRUARY 2020

SHEET NO. : /



ADMIN DIVISION
 Ministry of Health
 Roshanee Building
 Sosun Mogu
 Tel: 332 8887, Fax: 3328889