



EXISTING FLOOR PLAN (OPG)

SCALE: 1 : 100

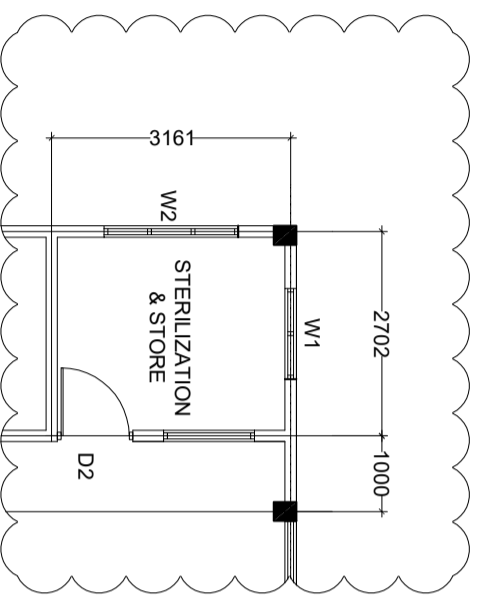

DRY WALL PARTITION PLAN (OPG)


SCALE: 1 : 100

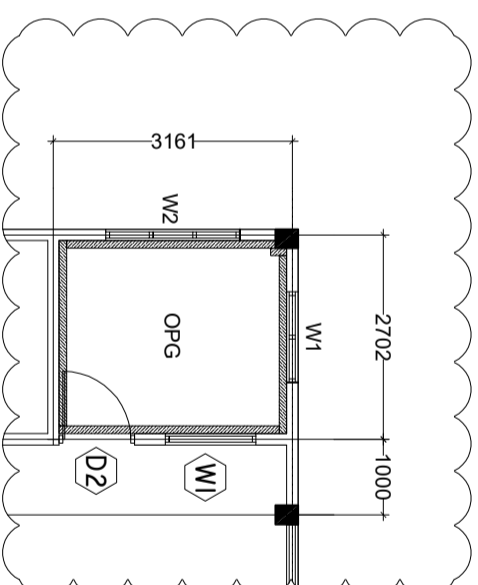

PARTITION (TYPE C)


PROPOSED FLOOR PLAN (OPG)

SCALE: 1 : 100

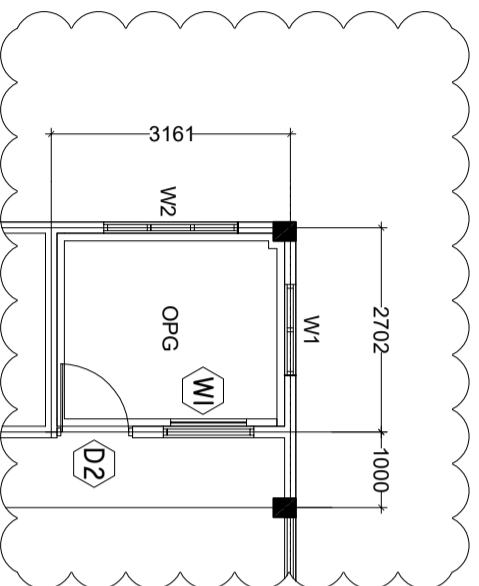

TRENCH PLAN (OPG)

SCALE: 1 : 100

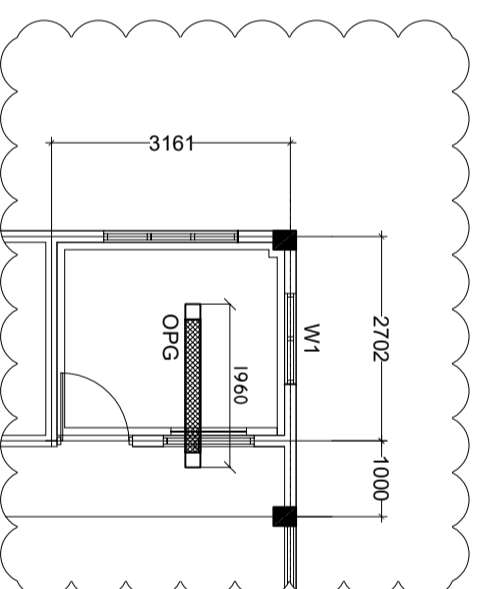

SHEET CONTENTS :

REVISION NOTES:

REVISED DRAWING OF TRUNGH

PROJECT:

RENOVATION OF

DENTAL DEPARTMENT

OF HDH,

KULHHDHFUSSHI

REGIONAL HOSPITAL

CLIENT:

MINISTRY OF HEALTH

LOCATION:

HDH, KULHHDHFUSSHI

CONTENTS: AS GIVEN

PROJECT MANAGER:

DESIGNER: ARIZ

CV/STR. ENGINEER:

SURVEYED BY: -

DRAWN BY: ARIZ

CHECKED BY:




DATE : MARCH 2020

SHEET NO. : /



DOORS AND WINDOWS SCHEDULE

Scale 1:50

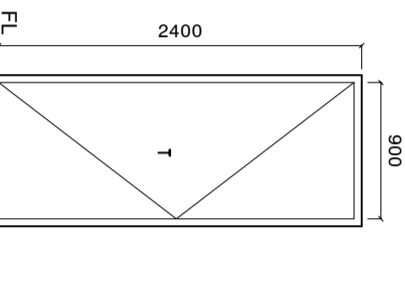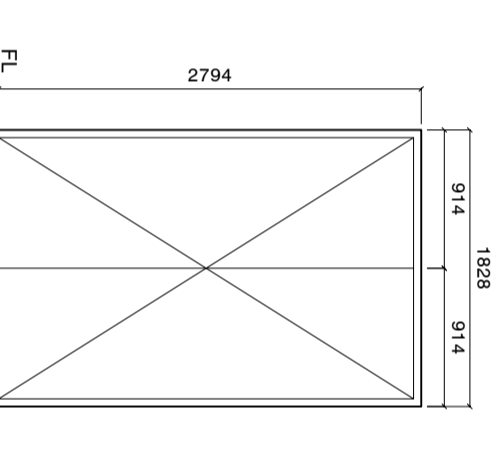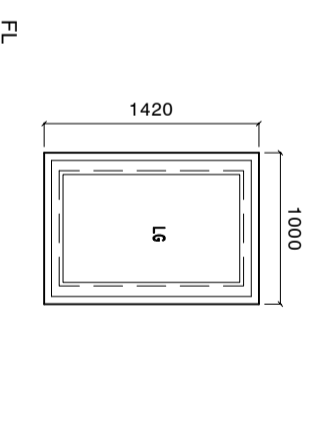SYMBOL	D1	D2	W1
ELEVATION			
LOCATION	GROUND FLOOR	GROUND FLOOR	GROUND FLOOR
QUANTITY			
FRAME	SOLID TIMBER FRAME DOOR	SOLID TIMBER FRAME DOOR	SOLID TIMBER FRAME DOOR
PANEL	TIMBER FRAME WITH 6MM PLY WOOD ON BOTH SIDE	TIMBER FRAME WITH 6MM PLY WOOD ON BOTH SIDE	TIMBER FRAME WITH 6MM PLY WOOD ON BOTH SIDE
FINISH	PAINT FINISH	PAINT FINISH	PAINT FINISH
HINGE	STAINLESS STEEL	STAINLESS STEEL	STAINLESS STEEL
LOCK	STATE MAKE	STATE MAKE	STATE MAKE
NOTE	ALL MEASUREMENTS TO BE CHECKED ON SITE	ALL MEASUREMENTS TO BE CHECKED ON SITE	ALL MEASUREMENTS TO BE CHECKED ON SITE

NOTE:

ALL MEASUREMENTS TO BE CHECKED ON SITE BEFORE FABRICATION
 T = PLYWOOD PANEL.
 LG = LEAD GLASS (WILL BE PROVIDED BY CLIENT)

SHEET CONTENTS :

REVISION NOTES:
 REVISED DRAWING OF TRUNCCH

PROJECT:
 RENOVATION OF
 DENTAL DEPARTMENT
 OF HDH,
 KULHUHFUSSHI
 REGIONAL HOSPITAL


CLIENT:
 MINISTRY OF HEALTH

LOCATION:
 HDH, KULHUHFUSSHI

CONTENTS: AS GIVEN
 PROJECT MANAGER:
 DESIGNER: ARIZ
 CIV/STR. ENGINEER:
 SURVEYED BY: -
 DRAWN BY: ARIZ
 CHECKED BY:
 DATE: MARCH 2020
 SHEET NO.: /

ELECTRICAL LAYOUT (OPG)

SCALE: 1 : 100

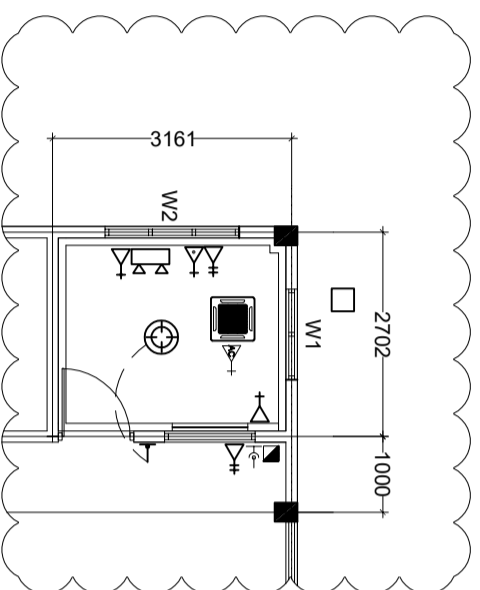

LEGEND

SYMBOL	DESCRIPTION
	LED BULB WITH 150MM DOWN LIGHT
	1 x 13 AMP SOCKET OUTLET (FLOOR MOUNT)
	2 x 13 AMP SOCKET OUTLET (600MM ABOVE FFL)
	1 x 15 AMP SOCKET OUTLET (600MM ABOVE FFL)
	1 x 15 AMP AC SOCKET OUTLET (300MM BLW, CEILING)
	ONE WAY SWITCH
	EMERGENCY LIGHT
	TELEPHONE SOCKET
	NETWORK SOCKET
	1 x 13 AMP SOCKET OUTLET (200MM BELOW CEILING)
	AC INDOOR UNIT, CEILING CASSETTE TYPE
	EARTH PIT

SHEET CONTENTS :

REVISION NOTES:

REVISED DRAWING OF TRUNCCH

PROJECT:
 RENOVATION OF
 DENTAL DEPARTMENT
 OF HDH,
 KULHUFUSSHI
 REGIONAL HOSPITAL

CLIENT:

MINISTRY OF HEALTH

LOCATION:
 HDH, KULHUFUSSHI

CONTENTS: AS GIVEN

PROJECT MANAGER:

DESIGNER: ARIZ

CIV/STR. ENGINEER:

SURVEYED BY: -

DRAWN BY: ARIZ

CHECKED BY:

DATE : MARCH 2020


SHEET NO. : /



ADMIN DIVISION
 Ministry of Health
 Roshanee Building
 Sosun Nagar
 Tel: 332 8887, Fax: 3328889


PARTITION DETAILS (TYPE C)

SCALE: 1 : 10

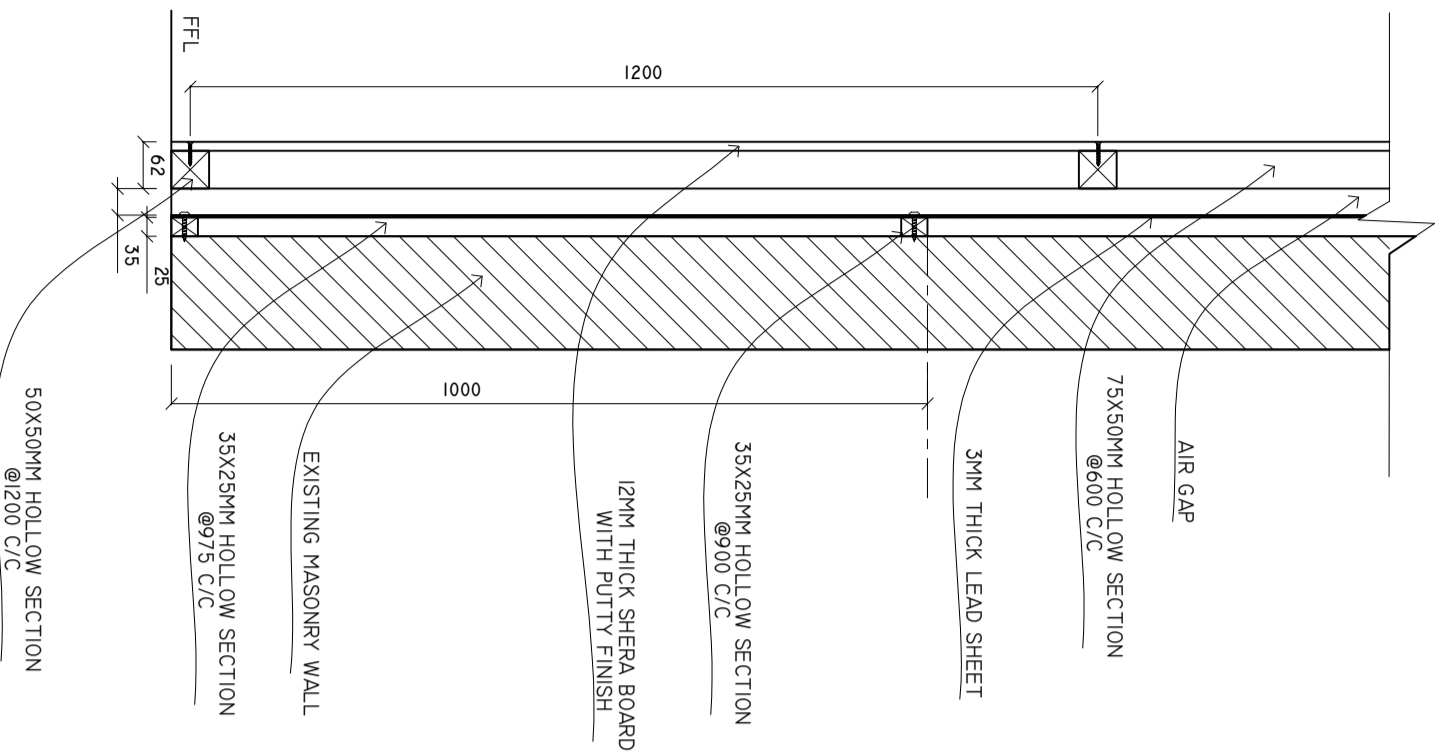


D2 DOOR AND PANEL SECTION

SCALE: 1 : 10

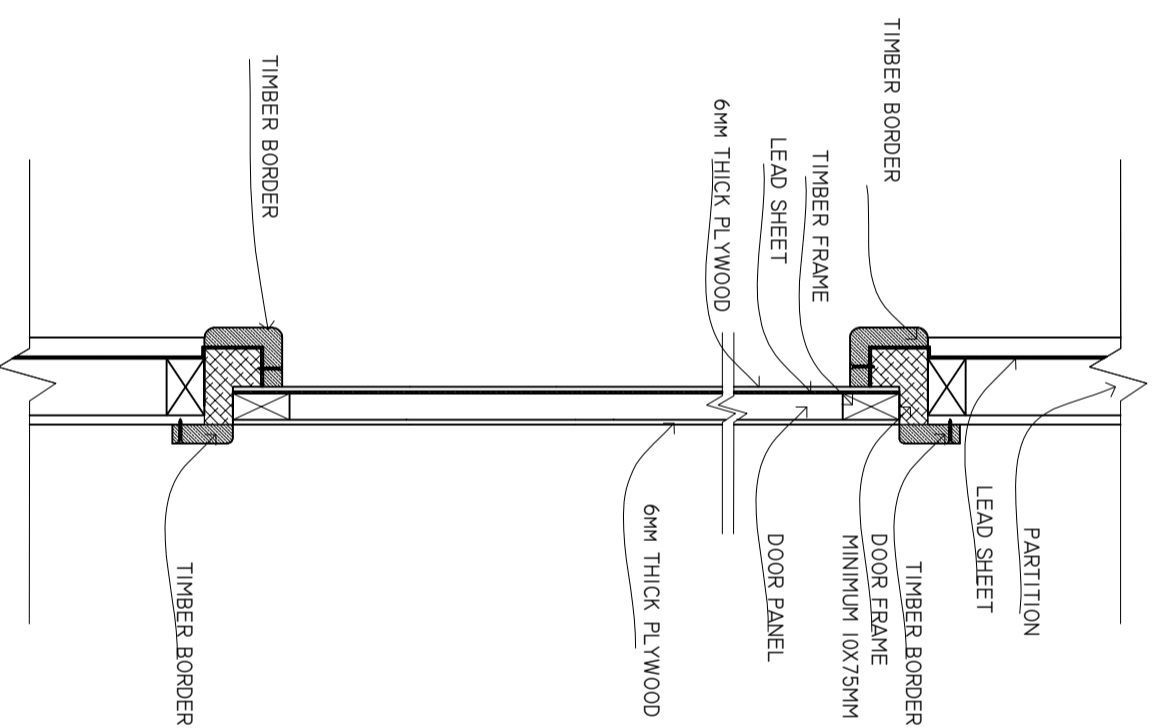

TRENCH DETAIL

SCALE: 1 : 10

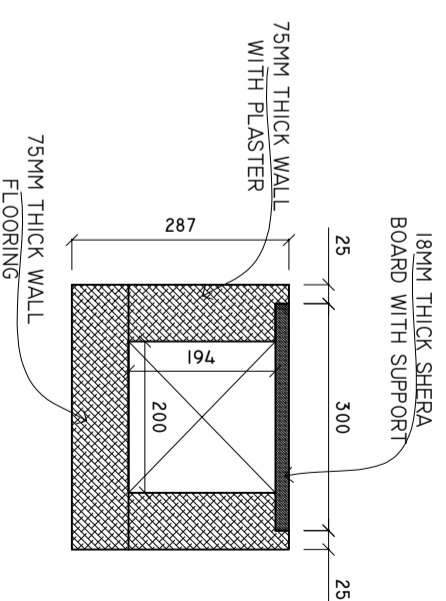

NOTE: ALL THE INTERNAL SURFACE TO BE APPLIED WITH WATERPROOFING COATING. WATERPROOFING COATING TO BE APPROVED BY CLIENT BEFORE APPL YING.

SHEET CONTENTS :

REVISION NOTES:

REVISED DRAWING OF TRUNCH

PROJECT:
RENOVATION OF
DENTAL DEPARTMENT
OF HDH,
KULHUFUSSHI
REGIONAL HOSPITAL

CLIENT:
MINISTRY OF HEALTH

LOCATION:
HDH, KULHUFUSSHI

CONTENTS: AS GIVEN

PROJECT MANAGER:

DESIGNER: ARIZ

CV/STR. ENGINEER:

SURVEYED BY: -

DRAWN BY: ARIZ


CHECKED BY:

DATE : MARCH 2020

SHEET NO. : /



ADMIN DIVISION
Ministry of Health
Roslanee Building
Soran Nagar
Tel: 332 8887, Fax: 3328889

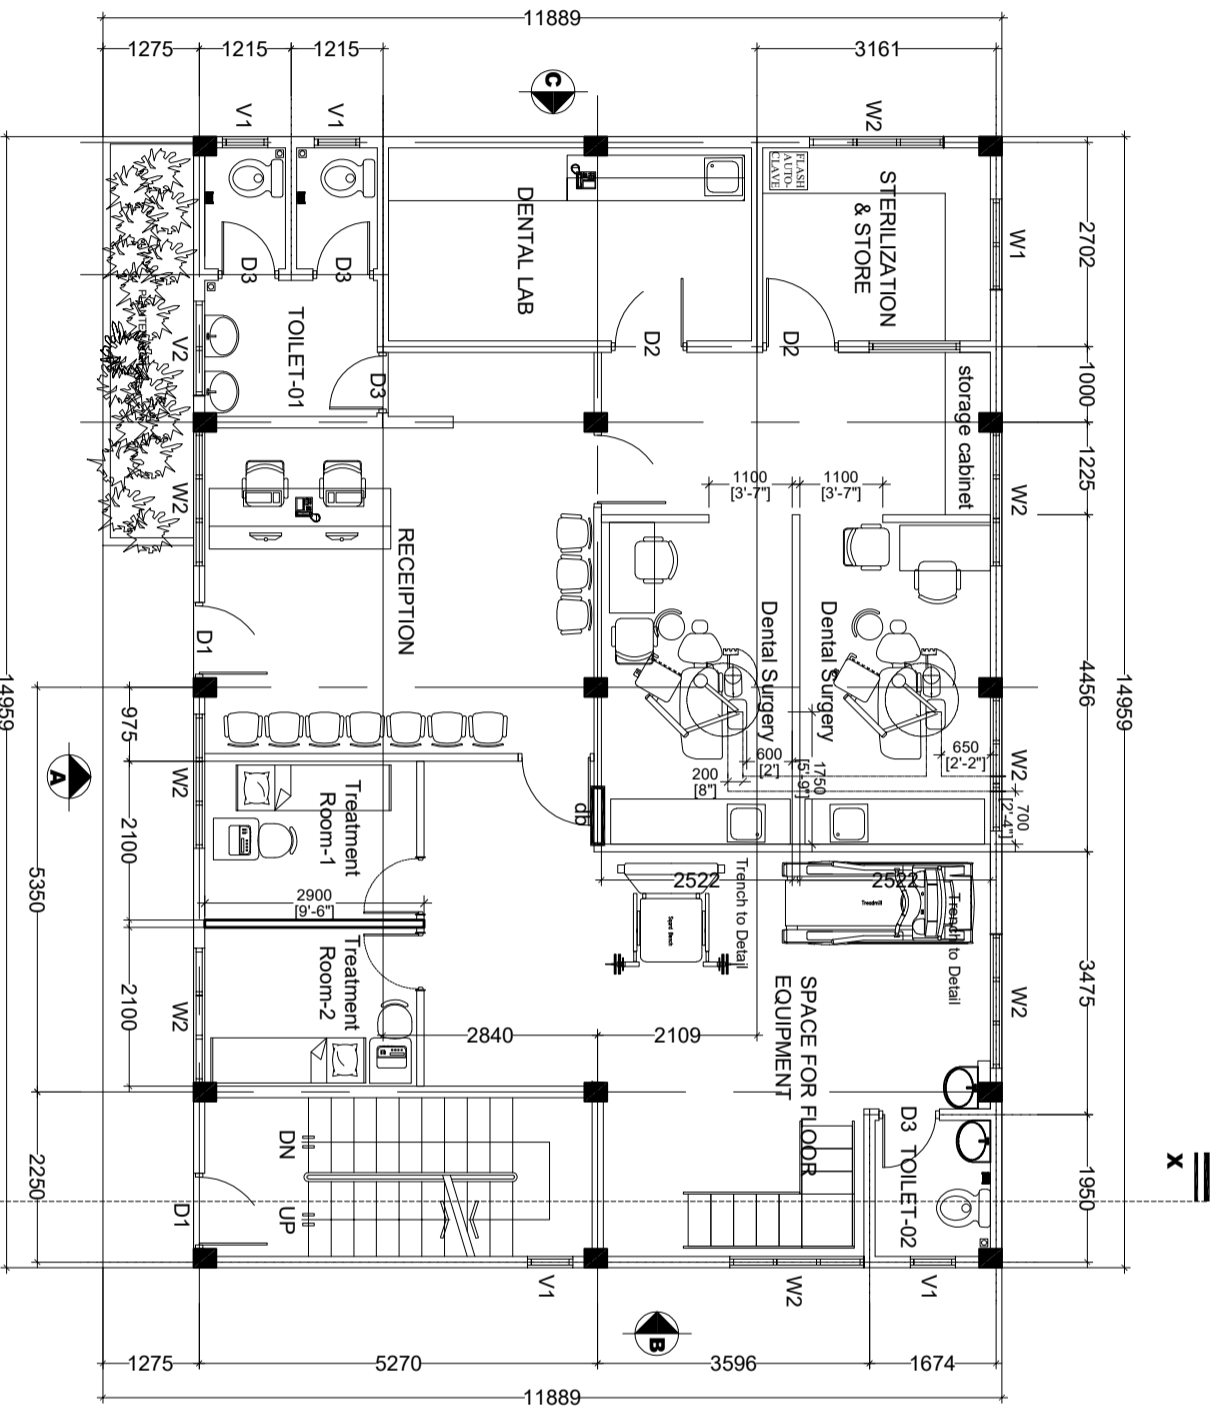

GROUND FLOOR PLAN DENTAL DEPARTMENT
SCALE 1:100

SHEET CONTENTS :

REVISION NOTES:

REVISED DRAWING OF TRUNCH

PROJECT:
RENOVATION OF
DENTAL DEPARTMENT
OF HDH,
KULHHDUFUSSHI
REGIONAL HOSPITAL

CLIENT:

MINISTRY OF HEALTH

LOCATION:
HDH, KULHHDUFUSSHI

CONTENTS: AS GIVEN

PROJECT MANAGER:

DESIGNER: ARIZ

CV/STR. ENGINEER:

SURVEYED BY: -

DRAWN BY: ARIZ

CHECKED BY:


DATE : MARCH 2020

SHEET NO. : /



FLOOR PLAN (CT AREA)

SCALE: 1 : 100

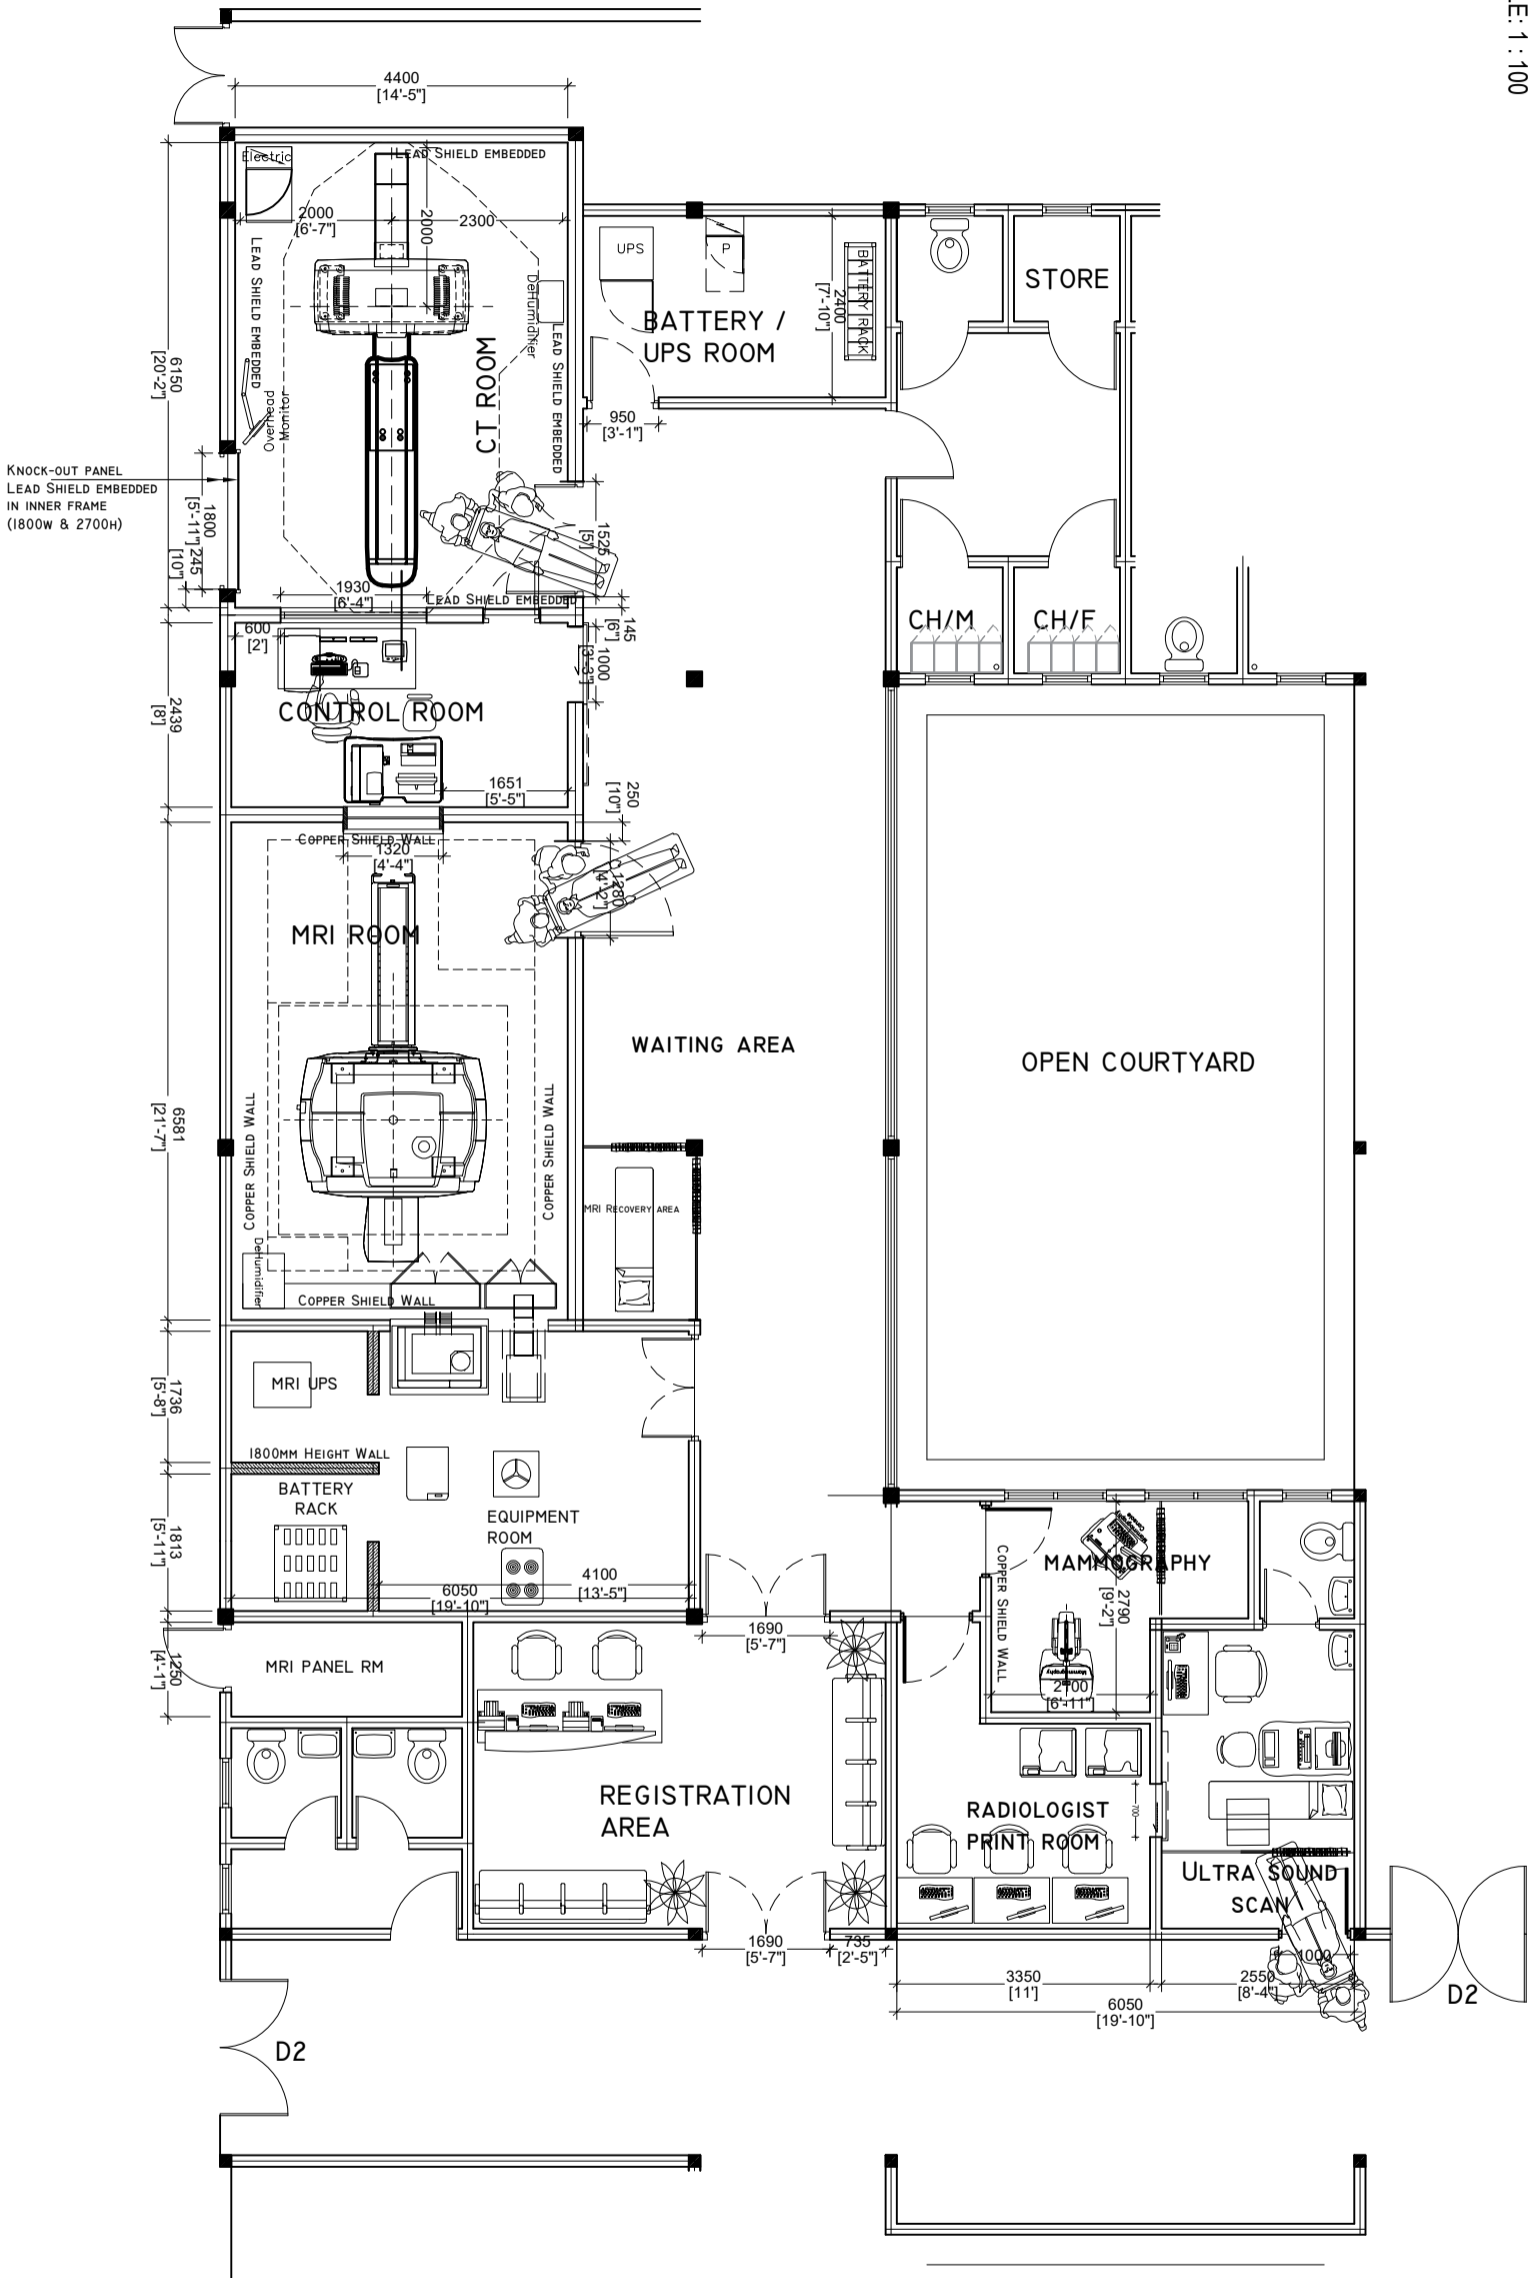

SHEET CONTENTS :

REVISION NOTES:

REVISED DRAWING OF TRUNCCH

PROJECT:
 RENOVATION OF
 DENTAL DEPARTMENT
 OF HDH,
 KULHDFUFSUSHI
 REGIONAL HOSPITAL

CLIENT:

MINISTRY OF HEALTH

LOCATION:
 HDH, KULHDFUFSUSHI

CONTENTS: AS GIVEN

PROJECT MANAGER:

DESIGNER: ARIZ

CV/STR. ENGINEER:

SURVEYED BY: -

DRAWN BY: ARIZ

CHECKED BY:


DATE: MARCH 2020

SHEET NO. : /



D2 DOOR AND PANEL SECTION

SCALE: 1 : 10

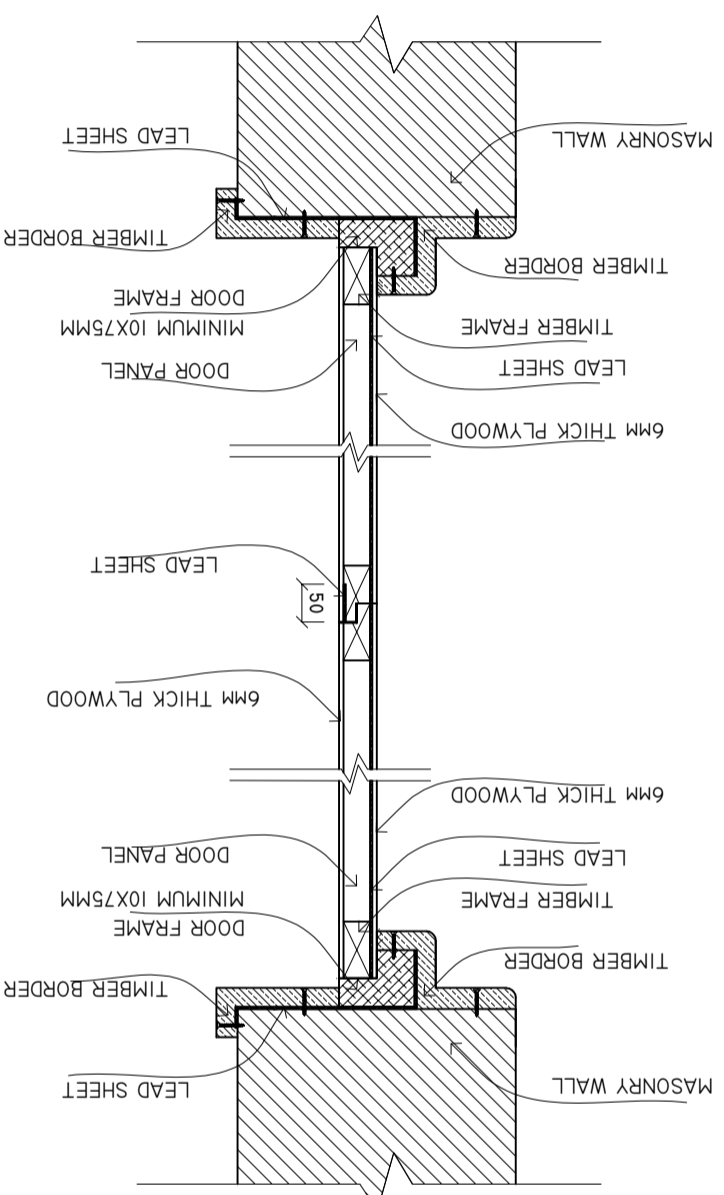

SHEET CONTENTS :

REVISION NOTES:

REVISED DRAWING OF TRUNCCH

PROJECT:
 RENOVATION OF
 DENTAL DEPARTMENT
 OF HDH,
 KULHUFUSSHI
 REGIONAL HOSPITAL

CLIENT:

MINISTRY OF HEALTH

LOCATION:
 HDH, KULHUFUSSHI

CONTENTS: AS GIVEN

PROJECT MANAGER:

DESIGNER: ARIZ

CIV/STR. ENGINEER:

SURVEYED BY: -

DRAWN BY: ARIZ

CHECKED BY:


DATE : MARCH 2020

SHEET NO. : /



TRENCH PLAN

SCALE: 1 : 100

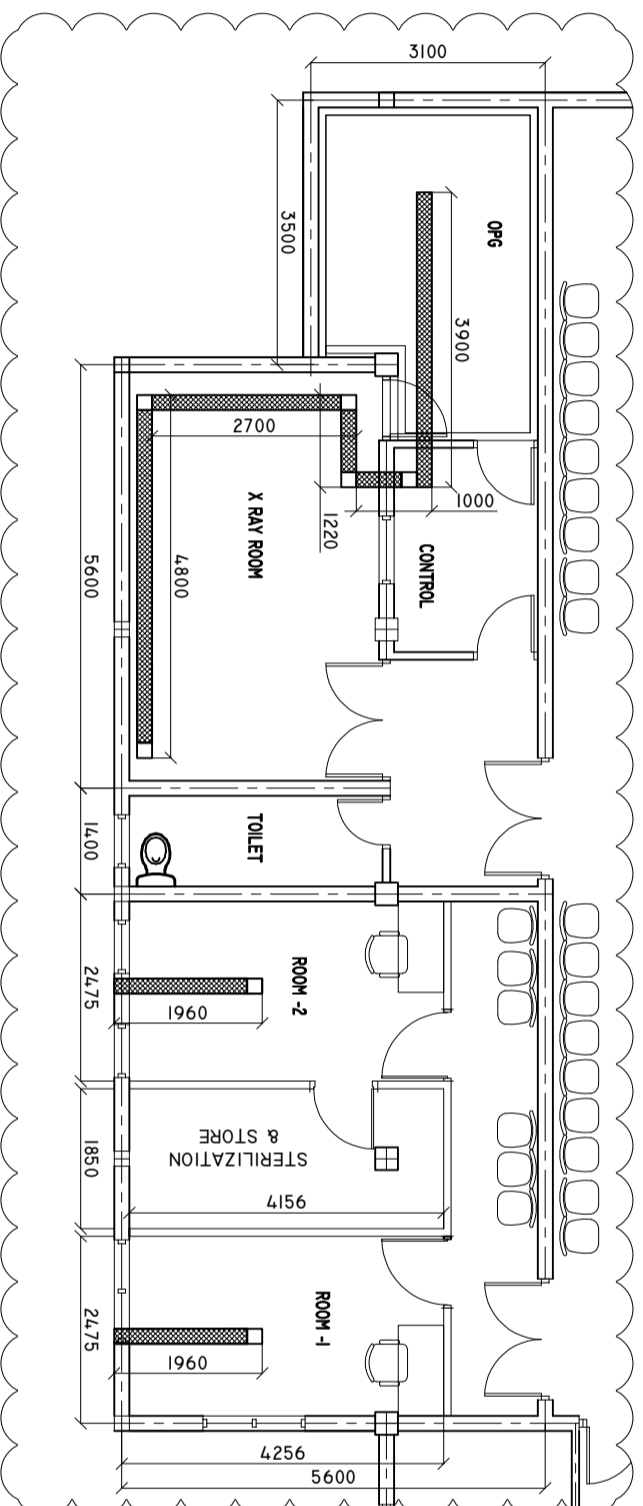

SHEET CONTENTS :

REVISION NOTES:

REVISED DRAWING OF TRUNCH

PROJECT:
RENOVATION OF
DENTAL DEPARTMENT
OF L. GAN REGIONAL
HOSPITAL

CLIENT:

MINISTRY OF HEALTH

LOCATION:

L. GAN

CONTENTS: AS GIVEN

PROJECT MANAGER:

DESIGNER: ARIZ

CIV/STR. ENGINEER:

SURVEYED BY: -

DRAWN BY: ARIZ

CHECKED BY:

DATE : FEBRUARY 2020

SHEET NO. : /



ADMIN DIVISION
Ministry of Health
Roslanee Building
Sosun Moga
Tel: 332 8887, Fax: 3328889