



# EXISTING FLOOR PLAN

SCALE: 1 : 100

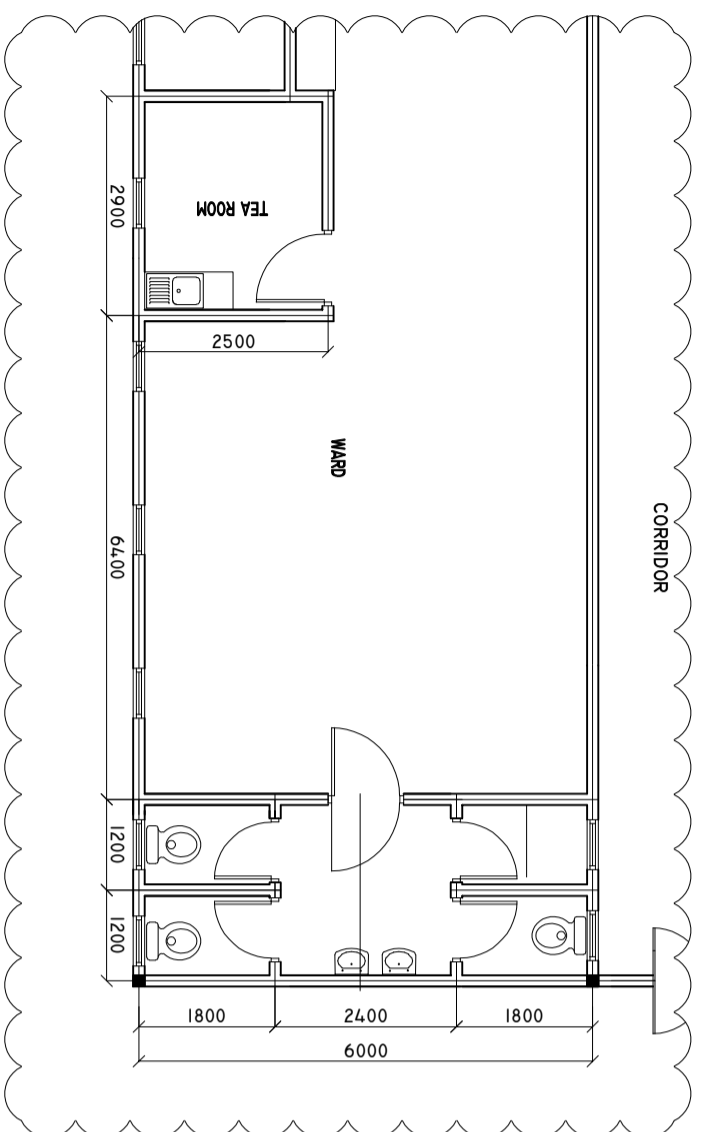

# PROPOSED FLOOR PLAN

SCALE: 1 : 100

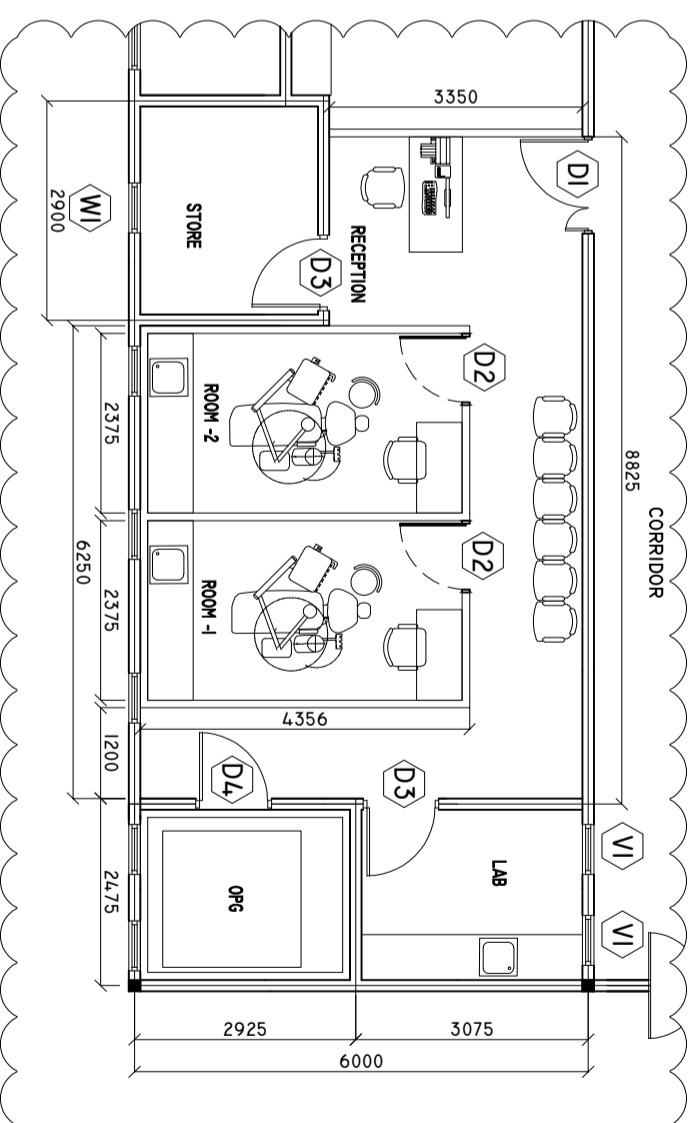

SHEET CONTENTS :

REVISION NOTES:

PROJECT:  
RENOVATION OF  
DENTAL DEPARTMENT  
OF L. GAN REGIONAL  
HOSPITAL

CLIENT:  
MINISTRY OF HEALTH

LOCATION:  
L. GAN

CONTENTS: AS GIVEN

PROJECT MANAGER:

DESIGNER: ARIZ

CV/STR. ENGINEER:

SURVEYED BY: -

DRAWN BY: ARIZ

CHECKED BY:


DATE : FEBRUARY 2020





SHEET NO. : /



# DRY WALL PARTITION PLAN

    
SCALE: 1 : 100

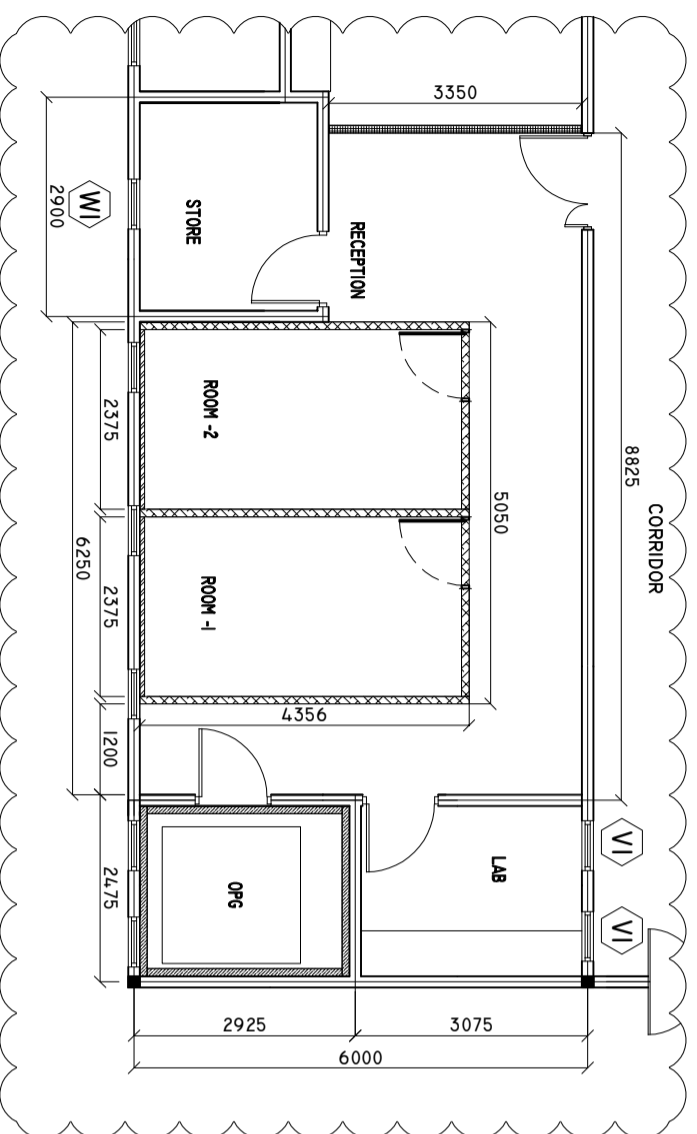

-  100MM THICK PARTITION (TYPE A)
-  65MM THICK PARTITION (TYPE B)
-  PARTITION (TYPE C)
-  70MM THICK PARTITION (TYPE D)

# WALL DETAILS PLAN

SCALE: 1 : 100

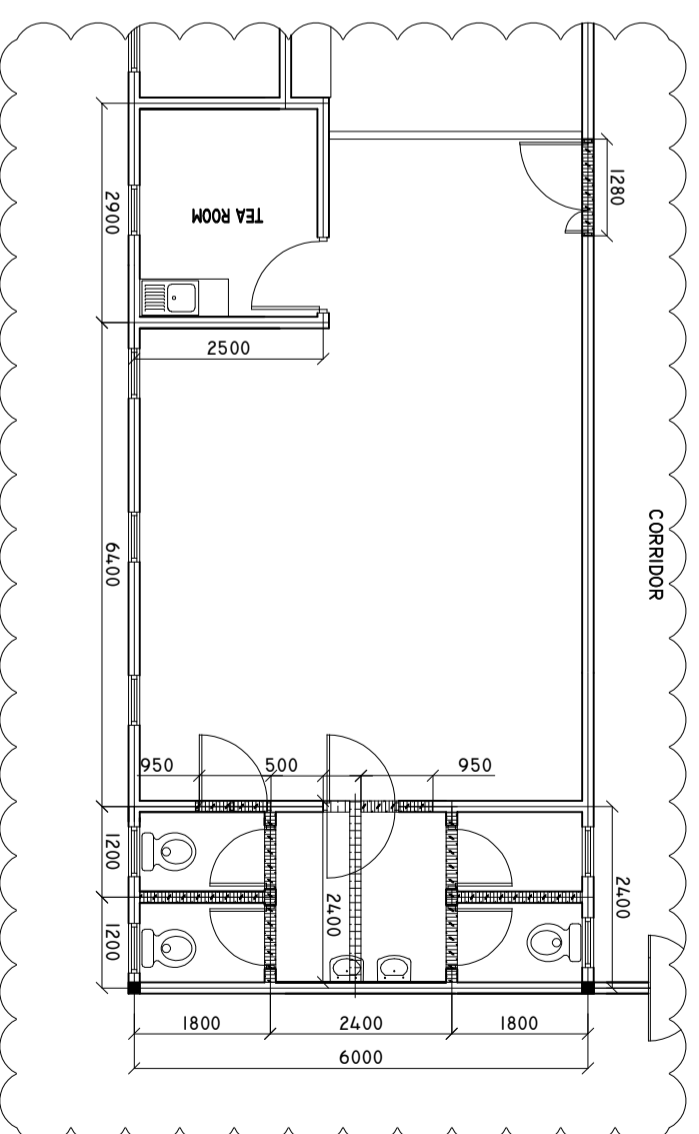

-  NEW MASONRY WALL
-  PARTITION TYPE 4

SHEET CONTENTS :

REVISION NOTES:

PROJECT:  
RENOVATION OF  
DENTAL DEPARTMENT  
OF L. L. GAN REGIONAL  
HOSPITAL

CLIENT:  
MINISTRY OF HEALTH

LOCATION:  
L. L. GAN

CONTENTS: AS GIVEN

PROJECT MANAGER:

DESIGNER: ARIZ

CV/STR. ENGINEER:

SURVEYED BY: -

DRAWN BY: ARIZ

CHECKED BY:

DATE : FEBRUARY 2020


SHEET NO. : /



ADMIN DIVISION  
Ministry of Health  
Roslanee building  
Sasun Nagar  
Tel: 332 8887, Fax: 3328889

# TRENCH PLAN

SCALE: 1 : 100

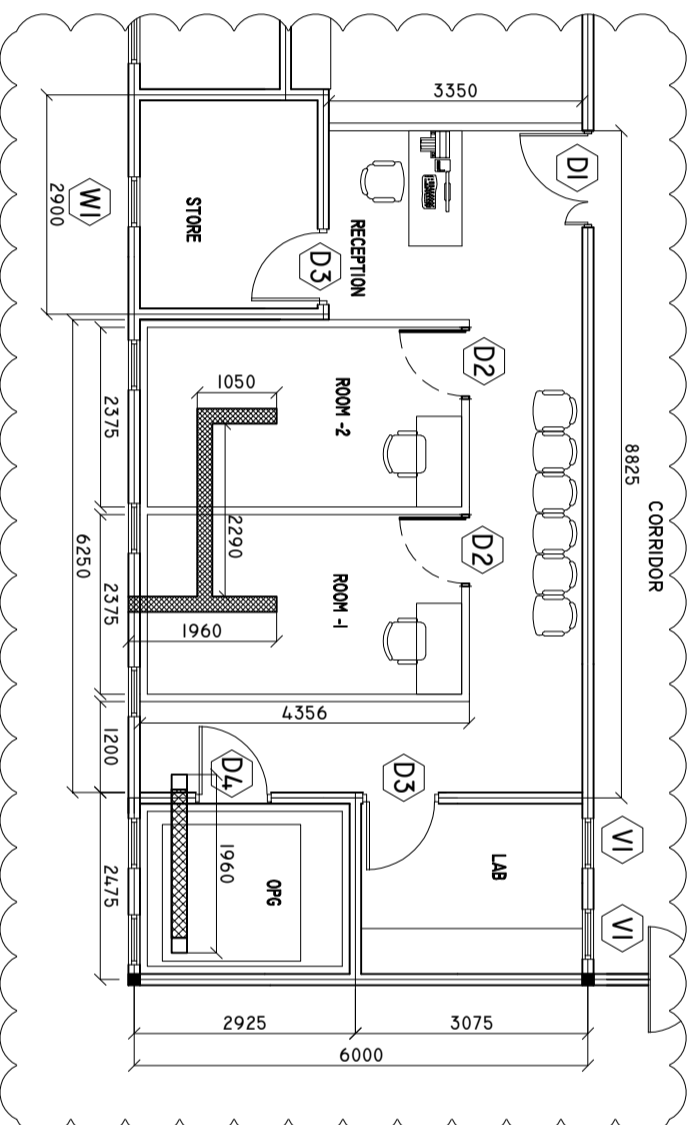

SHEET CONTENTS :

REVISION NOTES:

PROJECT:  
RENOVATION OF  
DENTAL DEPARTMENT  
OF L. L. GAN REGIONAL  
HOSPITAL

CLIENT:

MINISTRY OF HEALTH

LOCATION:

L. GAN

CONTENTS: AS GIVEN

PROJECT MANAGER:

DESIGNER: ARIZ

CIV/STR. ENGINEER:

SURVEYED BY: -

DRAWN BY: ARIZ

CHECKED BY:


DATE : FEBRUARY 2020

SHEET NO. : /




## AND PARTITION DETAILS (TYPE A)

SCALE: 1 : 10

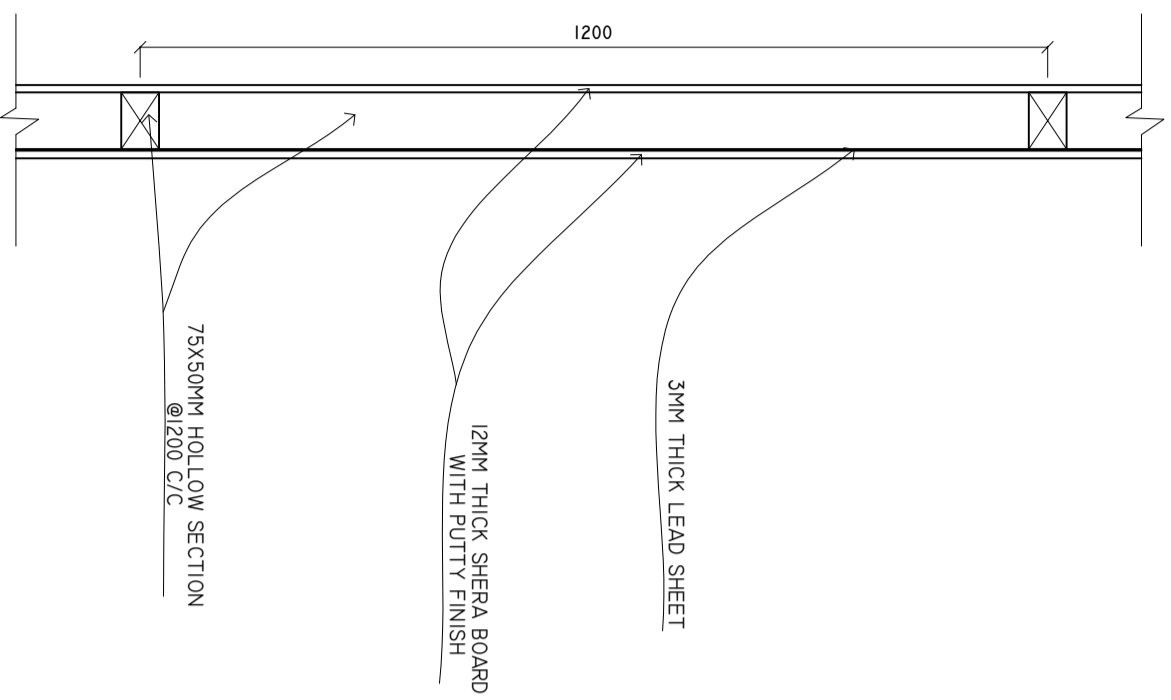

## PARTITION DETAILS (TYPE B)

SCALE: 1 : 10

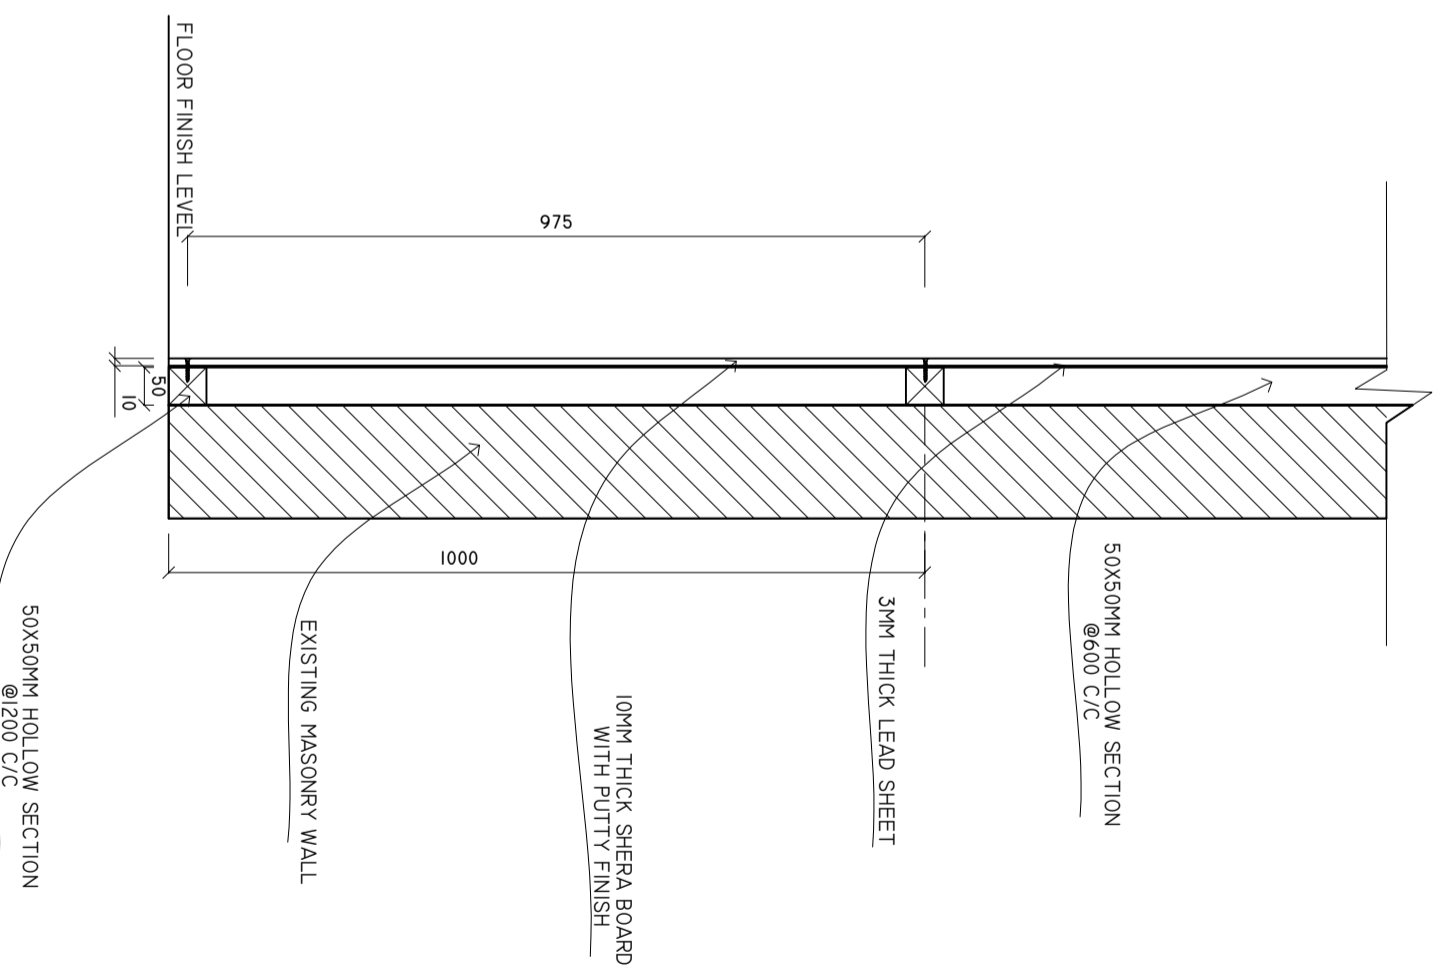

SHEET CONTENTS :

REVISION NOTES:

PROJECT:  
RENOVATION OF  
DENTAL DEPARTMENT  
OF L. GAN REGIONAL  
HOSPITAL

CLIENT:

MINISTRY OF HEALTH

LOCATION:

L. GAN

CONTENTS: AS GIVEN

PROJECT MANAGER:

DESIGNER: ARIZ

CV/STR. ENGINEER:

SURVEYED BY: -

DRAWN BY: ARIZ

CHECKED BY:


DATE : FEBRUARY 2020

SHEET NO. : /




## PARTITION DETAILS (TYPE C)

SCALE: 1 : 10

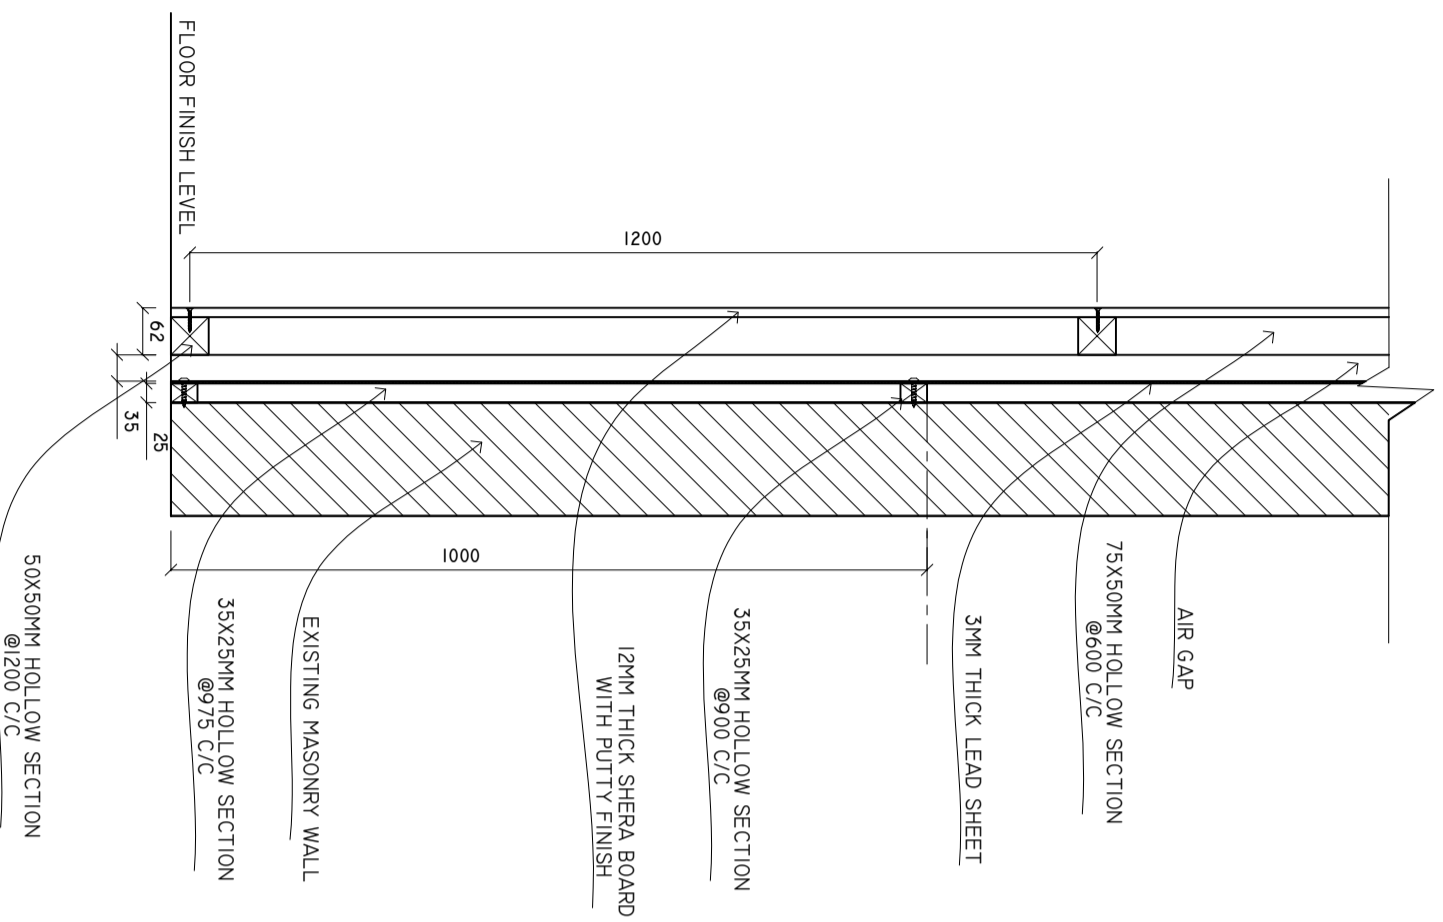

## PARTITION DETAILS (TYPE D)

SCALE: 1 : 10

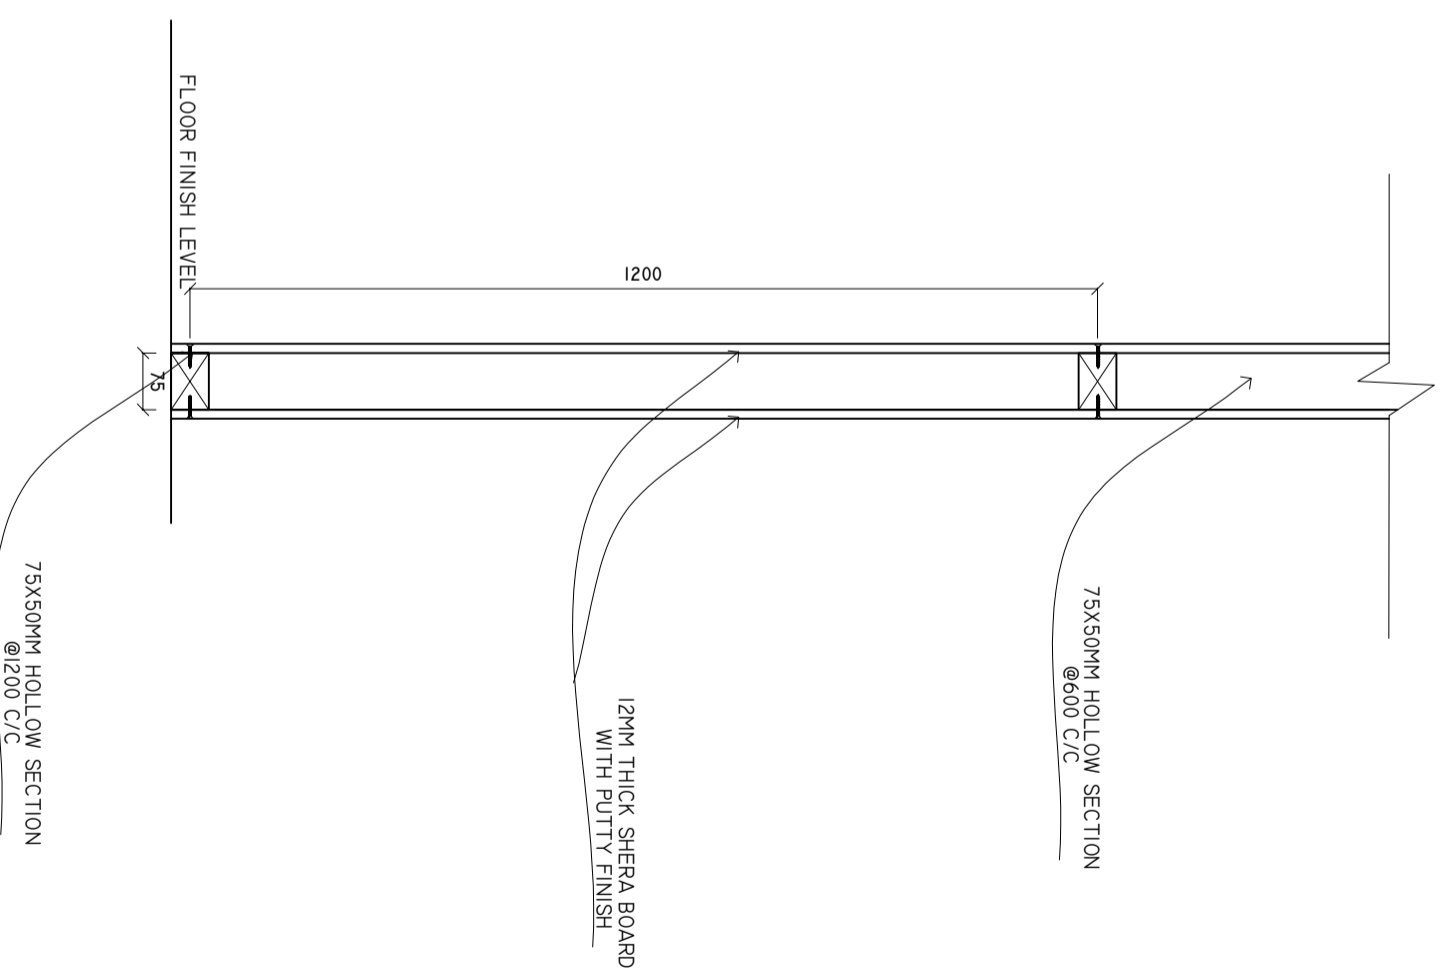

SHEET CONTENTS :

REVISION NOTES:

PROJECT:  
RENOVATION OF  
DENTAL DEPARTMENT  
OF L. GAN REGIONAL  
HOSPITAL

CLIENT:

MINISTRY OF HEALTH

LOCATION:

L. GAN

CONTENTS: AS GIVEN

PROJECT MANAGER:

DESIGNER: ARIZ

CV/STR. ENGINEER:

SURVEYED BY: -

DRAWN BY: ARIZ

CHECKED BY:

DATE : FEBRUARY 2020

SHEET NO. : /



# DOORS AND WINDOWS SCHEDULE

Scale 1:50

SYMBOL	D1	D2	D3	D4
ELEVATION				
LOCATION	GROUND FLOOR	GROUND FLOOR	GROUND FLOOR	GROUND FLOOR
QUANTITY				
FRAME	SOLID TIMBER FRAME DOOR	SOLID TIMBER FRAME DOOR	SOLID TIMBER FRAME DOOR	SOLID TIMBER FRAME DOOR
PANEL	DECORATIVE SOLID TIMBER PANEL	TIMBER FRAME WITH 6MM PLY WOOD ON BOTH SIDE	TIMBER FRAME WITH 6MM PLY WOOD ON BOTH SIDE	TIMBER FRAME WITH 6MM PLY WOOD ON BOTH SIDE
FINISH	PAINT FINISH	PAINT FINISH	PAINT FINISH	PAINT FINISH
HINGE	STAINLESS STEEL	STAINLESS STEEL	STAINLESS STEEL	STAINLESS STEEL
LOCK	STATE MAKE	STATE MAKE	STATE MAKE	STATE MAKE
NOTE	ALL MEASUREMENTS TO BE CHECKED ON SITE	ALL MEASUREMENTS TO BE CHECKED ON SITE	ALL MEASUREMENTS TO BE CHECKED ON SITE	ALL MEASUREMENTS TO BE CHECKED ON SITE

SYMBOL	W1	V1
ELEVATION		
LOCATION	GROUND FLOOR	GROUND FLOOR
QUANTITY	00 NOS	06 NOS
FRAME	ALUMINIUM FRAME DOOR	ALUMINIUM FRAME DOOR
PANEL	ALUMINIUM 60-80 MICRON POWDER COATING	ALUMINIUM 60-80 MICRON POWDER COATING
FINISH	ALUMINIUM IN 60-80 MICRON POWDER COATING	ALUMINIUM IN 60-80 MICRON POWDER COATING
HINGE	STAINLESS STEEL	STAINLESS STEEL
LOCK	STATE MAKE	STATE MAKE
NOTE	ALL MEASUREMENTS TO BE CHECKED ON SITE	ALL MEASUREMENTS TO BE CHECKED ON SITE

NOTE:

ALL MEASUREMENTS TO BE CHECKED ON SITE BEFORE FABRICATION  
 T = PLYWOOD PANEL.  
 LG = LEAD GLASS (WILL BE PROVIDED BY CLIENT)

SHEET CONTENTS :

PROJECT:  
 RENOVATION OF  
 DENTAL DEPARTMENT  
 OF L. GAN REGIONAL  
 HOSPITAL

CLIENT:

MINISTRY OF HEALTH

LOCATION:

L. GAN

CONTENTS: AS GIVEN

PROJECT MANAGER:

DESIGNER: ARIZ

CV/STR. ENGINEER:

SURVEYED BY: -

DRAWN BY: ARIZ

CHECKED BY:


DATE : FEBRUARY 2020

SHEET NO. : /




## D2 & D4 DOOR AND PANEL SECTION

SCALE: 1 : 10

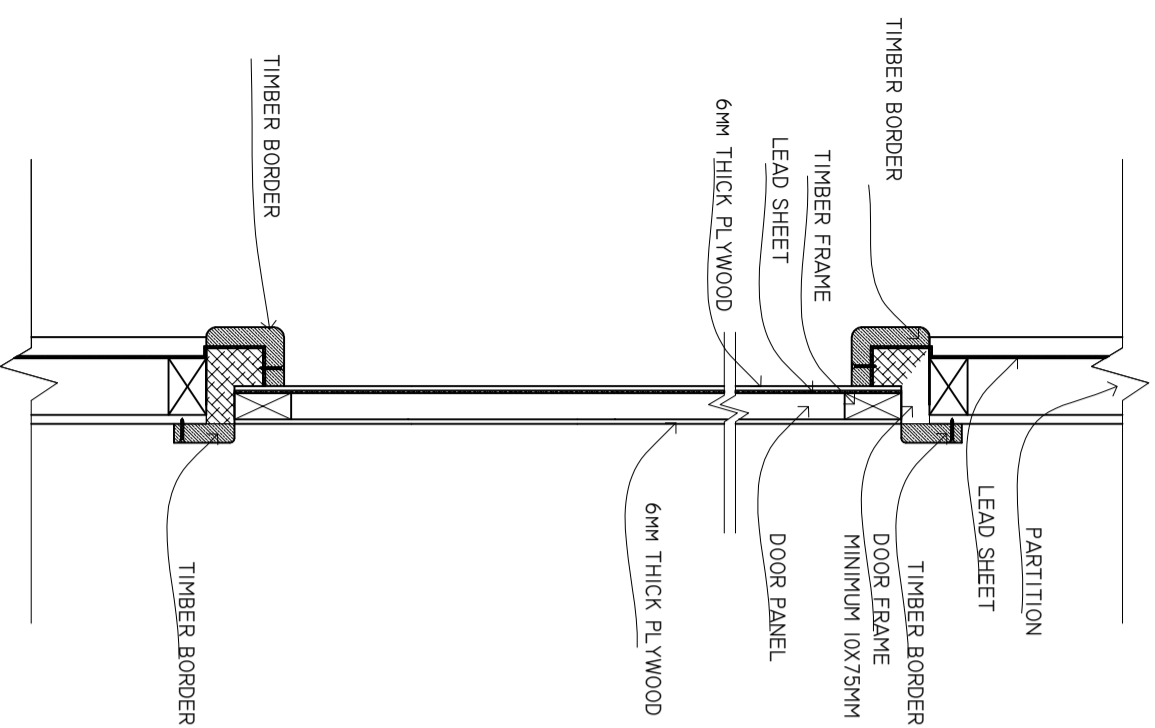

## TRENCH DETAIL

SCALE: 1 : 10

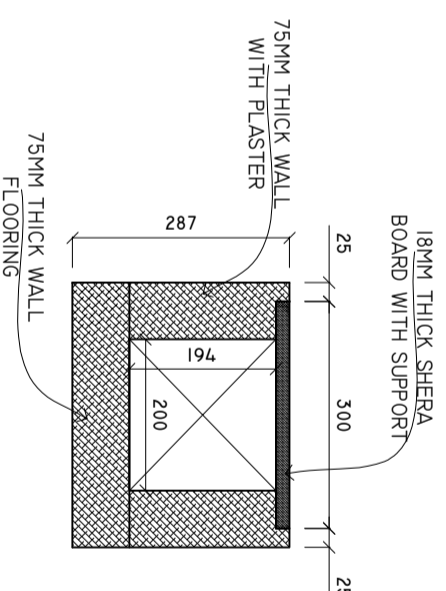

NOTE: ALL THE INTERNAL SURFACE TO BE APPLIED WITH WATERPROOFING COATING. WATERPROOFING COATING TO BE APPROVED BY CLIENT BEFORE APPLYING.

SHEET CONTENTS :

REVISION NOTES:

PROJECT:  
RENOVATION OF  
DENTAL DEPARTMENT  
OF L. GAN REGIONAL  
HOSPITAL

CLIENT:

MINISTRY OF HEALTH

LOCATION:

L. GAN

CONTENTS: AS GIVEN

PROJECT MANAGER:

DESIGNER: ARIZ

CV/STR. ENGINEER:

SURVEYED BY: -

DRAWN BY: ARIZ

CHECKED BY:


DATE : FEBRUARY 2020

SHEET NO. : /



# ELECTRICAL LAYOUT

SCALE: 1 : 100

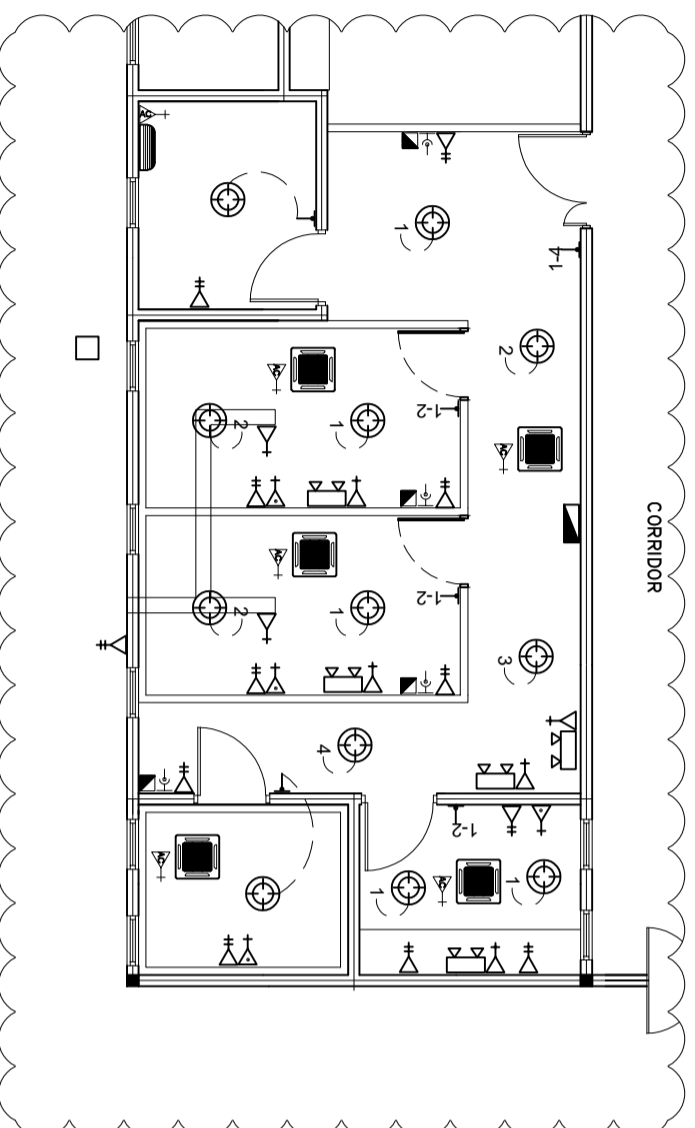

## LEGEND

SYMBOL	DESCRIPTION
	LED BULB WITH 150MM DOWN LIGHT
	1 x 13 AMP SOCKET OUTLET ( FLOOR MOUNT )
	2 x 13 AMP SOCKET OUTLET (600MM ABOVE FFL)
	1 x 15 AMP SOCKET OUTLET (600MM ABOVE FFL)
	1 x 15 AMP AC SOCKET OUTLET ( 300MM BLW, CEILING)
	TWO GANG SWITCH
	ONE WAY SWITCH
	EMERGENCY LIGHT
	DISTRIBUTION BOARD ( WALL EMBEDDED )
	TELEPHONE SOCKET
	NETWORK SOCKET
	1 x 13 AMP SOCKET OUTLET (200MM BELOW CEILING)
	AC OUTDOOR UNIT
	AC INDOOR UNIT, CEILING CASSETTE TYPE
	EARTH PIT
	AC WALL MOUNT UNIT

SHEET CONTENTS :

REVISION NOTES:

PROJECT:  
RENOVATION OF  
DENTAL DEPARTMENT  
OF L. GAN REGIONAL  
HOSPITAL

CLIENT:

MINISTRY OF HEALTH

LOCATION:

L. GAN

CONTENTS: AS GIVEN

PROJECT MANAGER:

DESIGNER: ARIZ

CIV/STR. ENGINEER:

SURVEYED BY: -

DRAWN BY: ARIZ

CHECKED BY:

DATE : FEBRUARY 2020


SHEET NO. : /






# BED SIDE RAILING LAYOUT

SCALE: 1 : 100

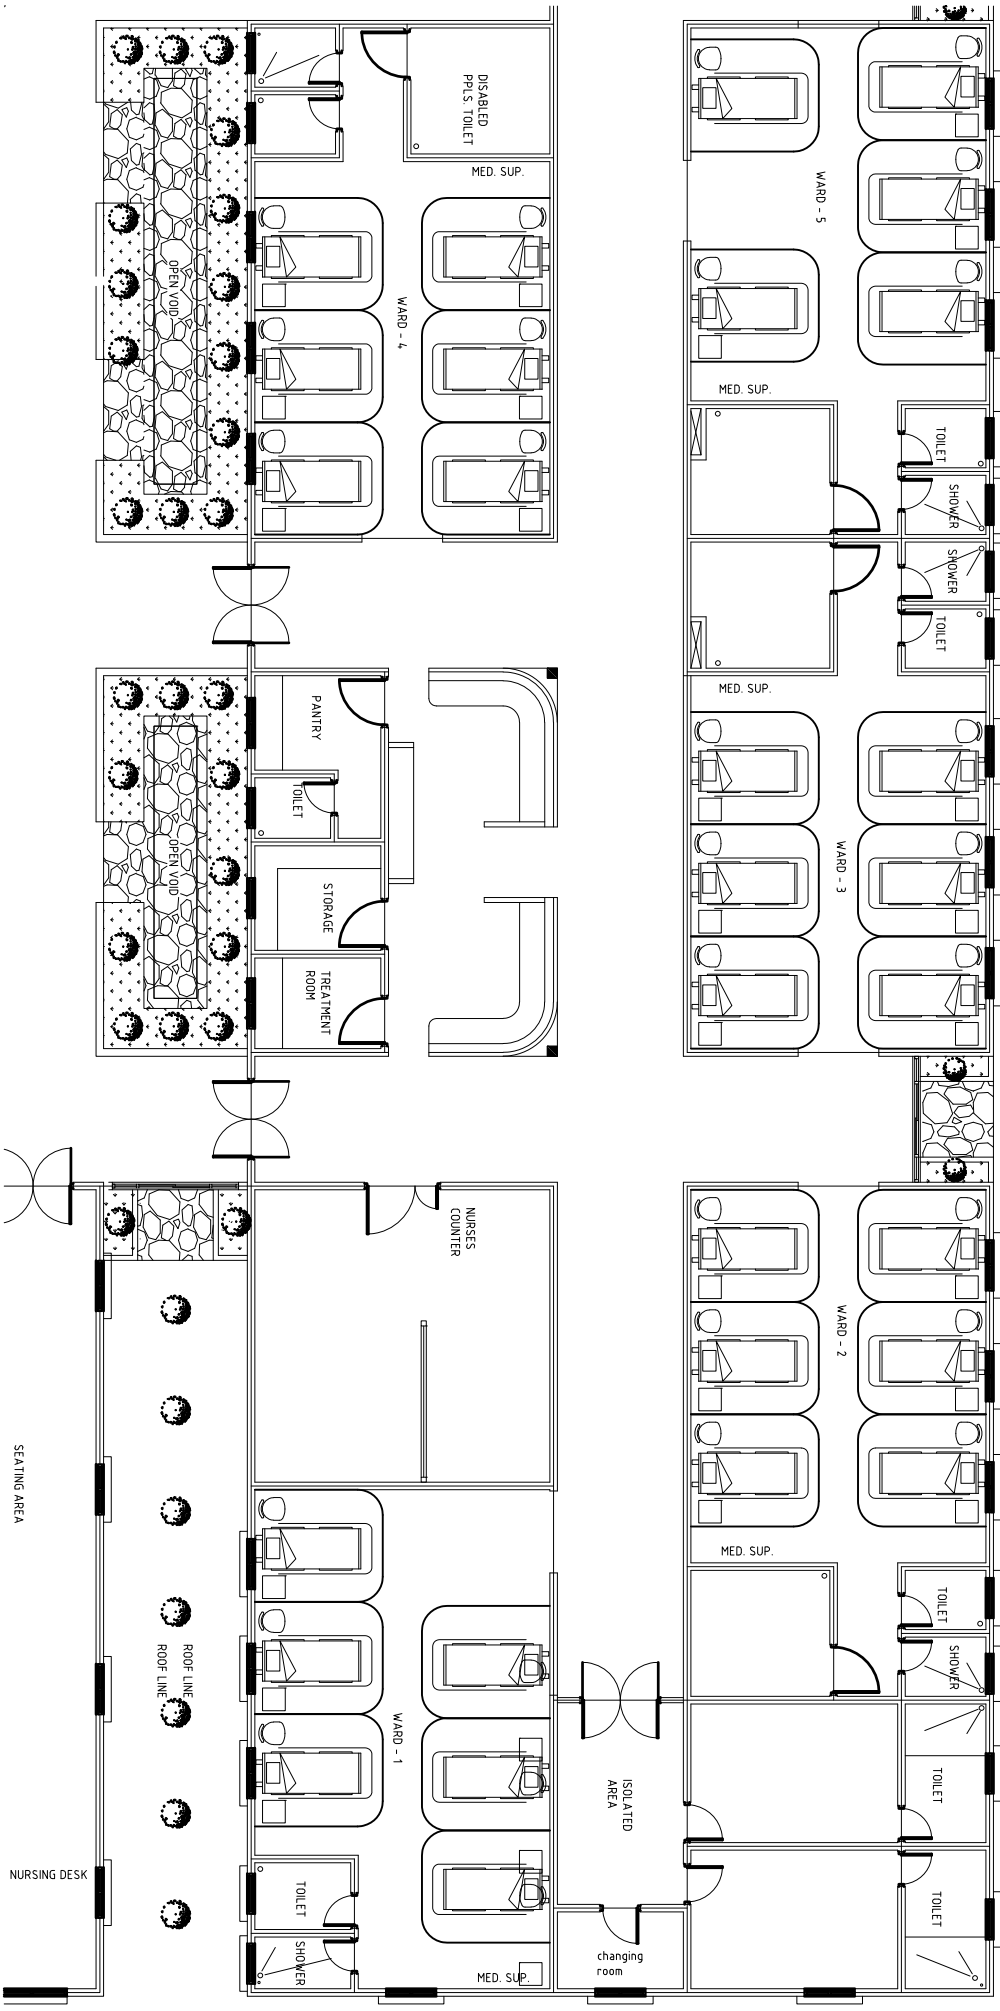


# RAILING PLAN FOR BED SIDE CURATAIN

SCALE: 1 : 25

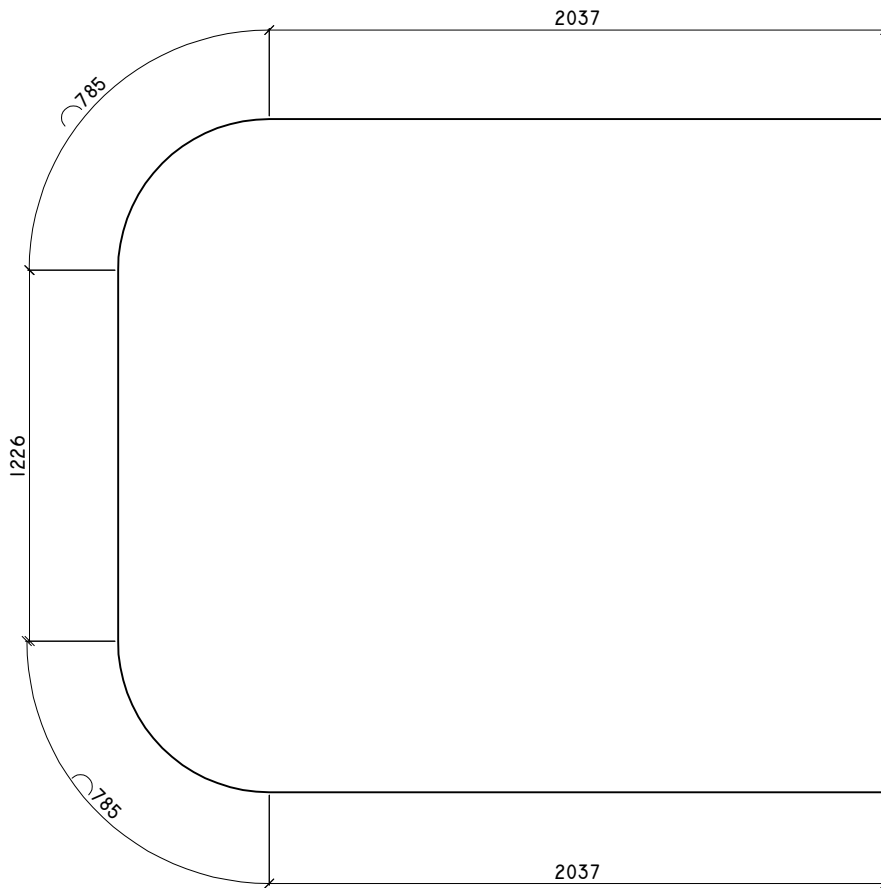

# TRENCH PLAN

SCALE: 1 : 100

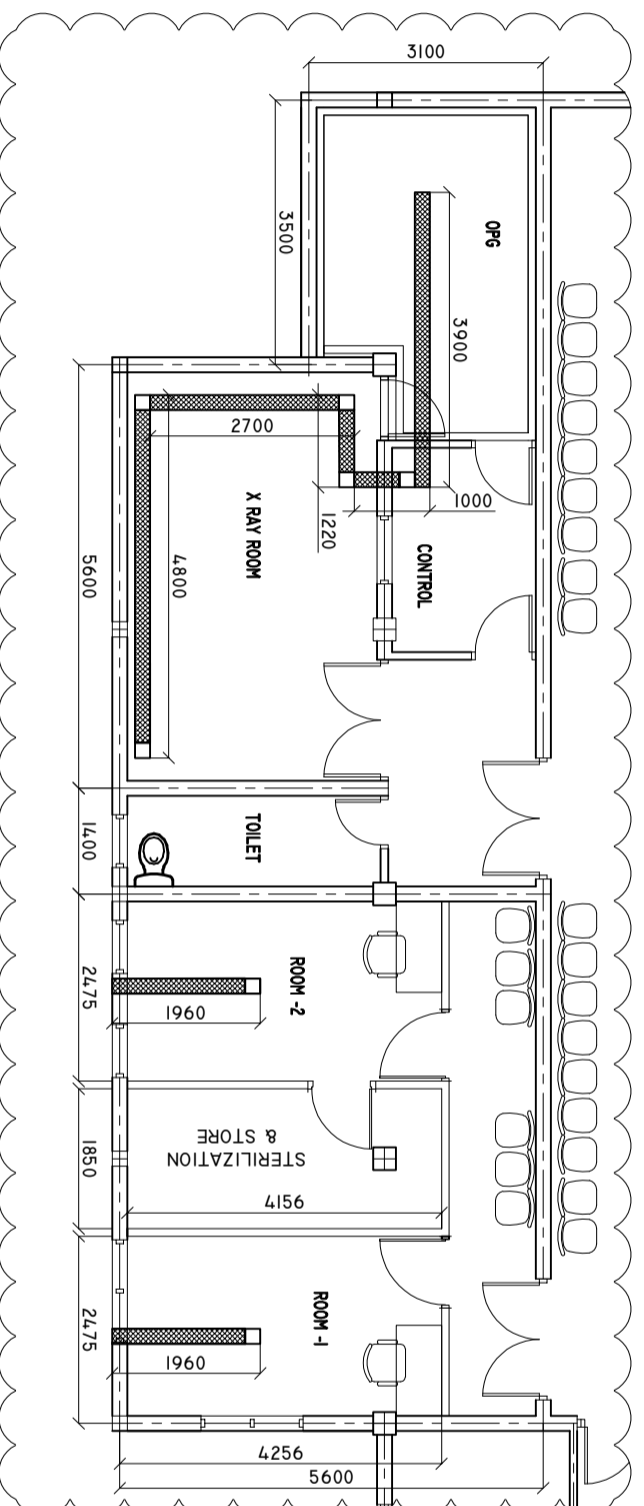

SHEET CONTENTS :

REVISION NOTES:

REVISED DRAWING OF TRUNCH

PROJECT:  
 RENOVATION OF  
 DENTAL DEPARTMENT  
 OF L. L. GAN REGIONAL  
 HOSPITAL

CLIENT:

MINISTRY OF HEALTH

LOCATION:

L. GAN

CONTENTS: AS GIVEN

PROJECT MANAGER:

DESIGNER: ARIZ

CIV/STR. ENGINEER:

SURVEYED BY: -

DRAWN BY: ARIZ

CHECKED BY:

DATE : FEBRUARY 2020

SHEET NO. : /

