



EXISTING FLOOR PLAN

SCALE : 1 : 100

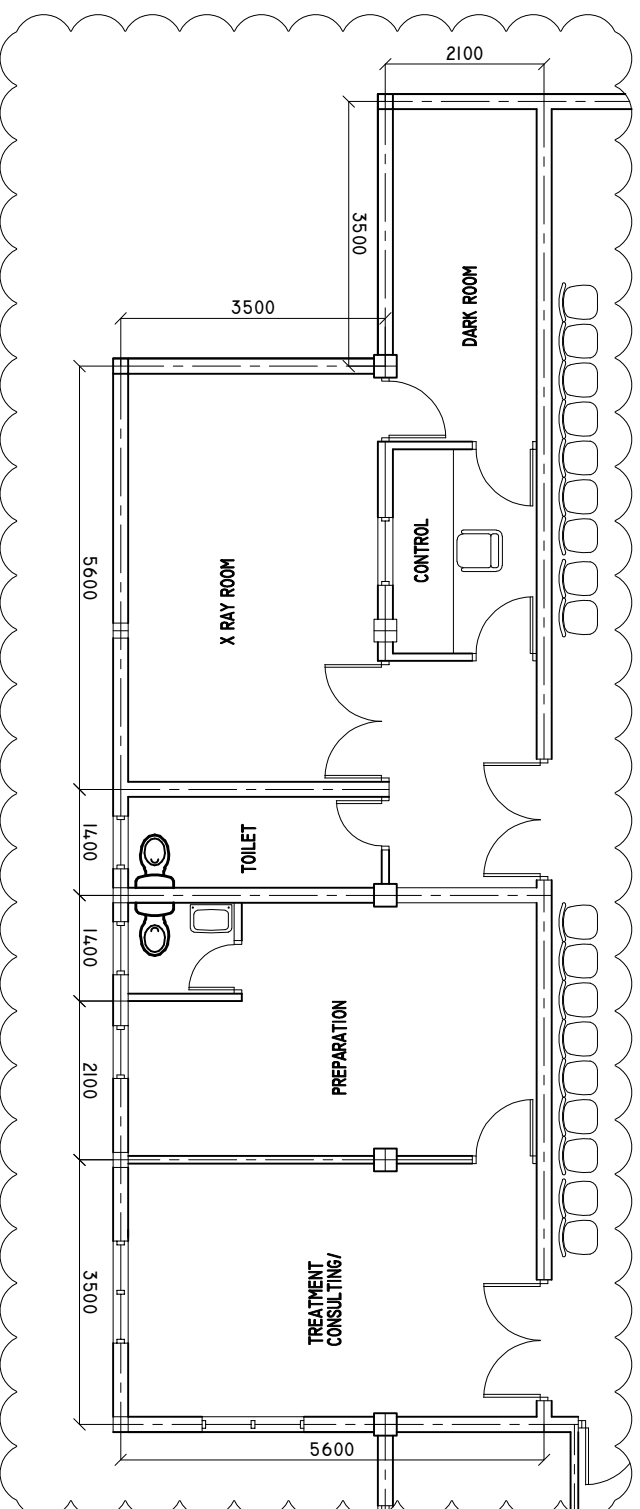

PROPOSED FLOOR PLAN

SCALE : 1 : 100

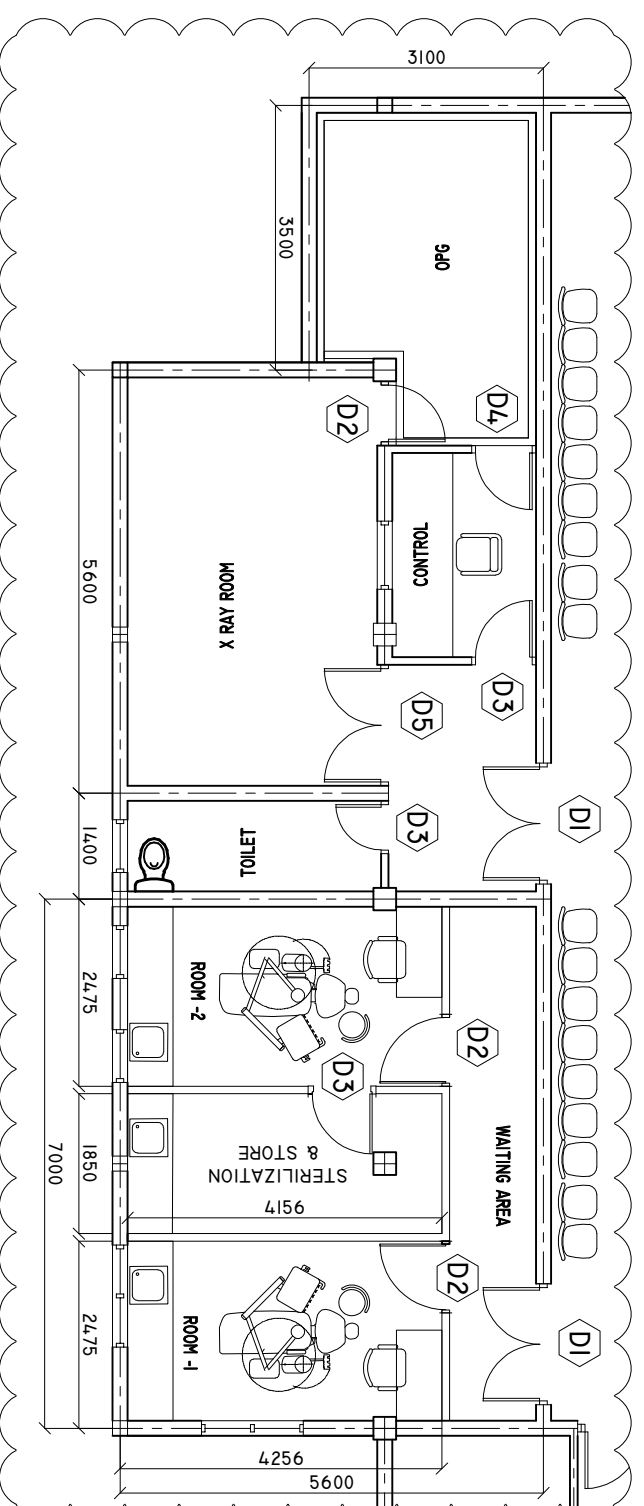

SHEET CONTENTS :

REVISION NOTES:

PROJECT:
 RENOVATION OF
 RADIOLOGY
 DEPARTMENT AT R.
 UGOOFAARU REGIONAL
 HOSPITAL

CLIENT:
 MINISTRY OF HEALTH

LOCATION:
 R. UGOOFAARU

CONTENTS: AS GIVEN

PROJECT MANAGER:

DESIGNER: ARIZ

CV/STR. ENGINEER:

SURVEYED BY: -

DRAWN BY: ARIZ

CHECKED BY:


DATE : FEBRUARY 2020

SHEET NO. : /



WALLS DETAILS


SCALE: 1 : 100

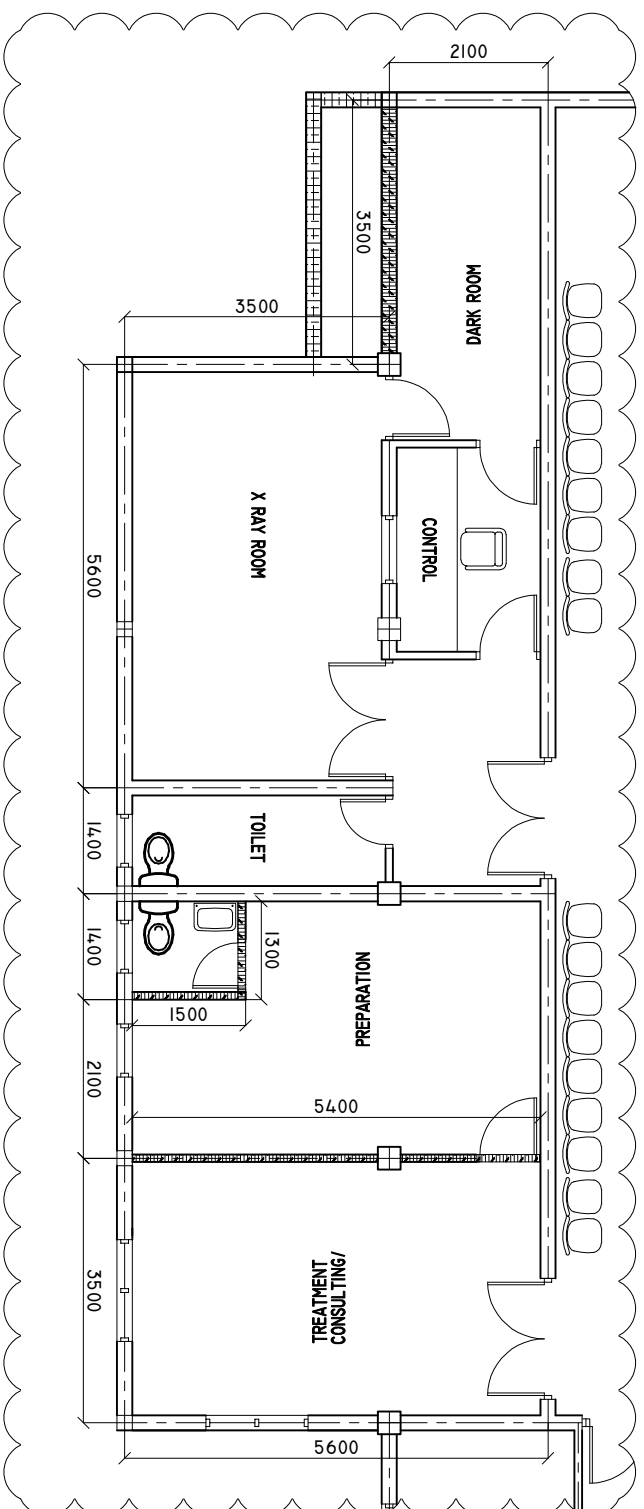




NEW MASONRY WALL
WALLS TO BE DEMOLISH

DRY WALL PARTITION PLAN

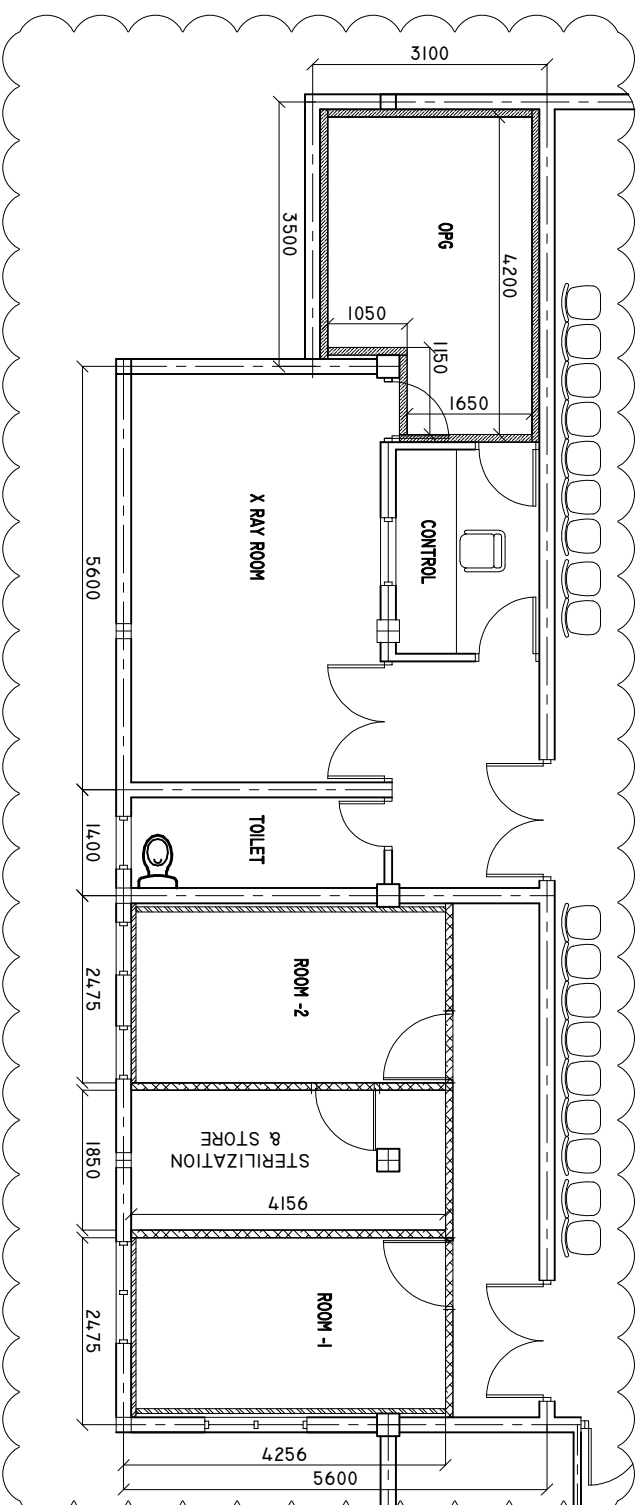SCALE: 1 : 100



-  100MM THICK PARTITION (TYPE A)
-  65MM THICK PARTITION (TYPE B)
-  PARTITION (TYPE C)

SHEET CONTENTS :

REVISION NOTES:

PROJECT:
RENOVATION OF
RADIOLOGY
DEPARTMENT AT R.
UGOOFAARU REGIONAL
HOSPITAL

CLIENT:
MINISTRY OF HEALTH

LOCATION:
R. UGOOFAARU

CONTENTS: AS GIVEN

PROJECT MANAGER:

DESIGNER: ARIZ

CV/STR. ENGINEER:

SURVEYED BY: -

DRAWN BY: ARIZ

CHECKED BY:

DATE : FEBRUARY 2020


SHEET NO. : /



ADMIN DIVISION
Ministry of Health
Rosshanee Building
Saxum Mogel
Tel: 332 8887, Fax: 3328889

TRENCH PLAN

SCALE: 1 : 100

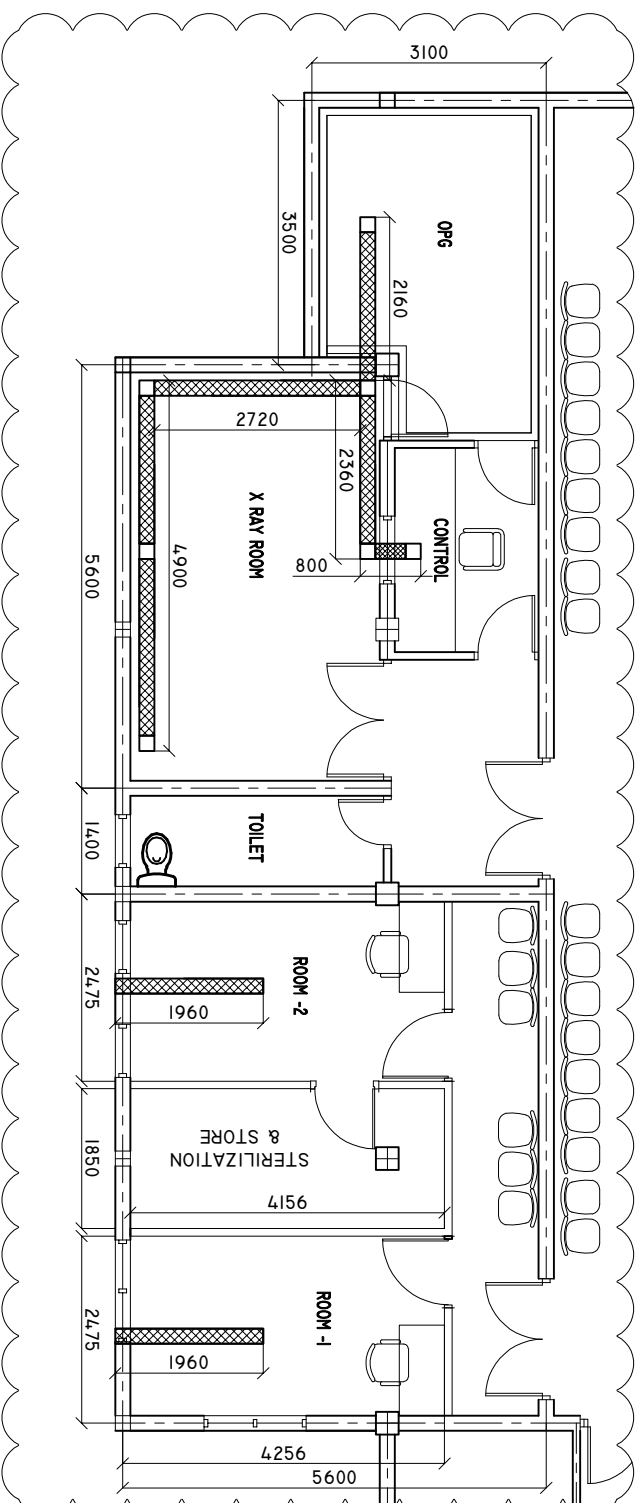

SHEET CONTENTS :

REVISION NOTES:

PROJECT:
 RENOVATION OF
 RADIOLOGY
 DEPARTMENT AT R.
 UGOOFARU REGIONAL
 HOSPITAL

CLIENT:
 MINISTRY OF HEALTH

LOCATION:
 R. UGOOFARU

CONTENTS: AS GIVEN

PROJECT MANAGER:

DESIGNER: ARIZ

CIV/STR. ENGINEER:

SURVEYED BY: -

DRAWN BY: ARIZ

CHECKED BY:

DATE : FEBRUARY 2020


SHEET NO. : /



ADMIN DIVISION
 Ministry of Health
 Roshanee Building
 Sosun Moga
 Tel: 332 8887, Fax: 3328889

ELECTRICAL LAYOUT

SCALE: 1 : 100

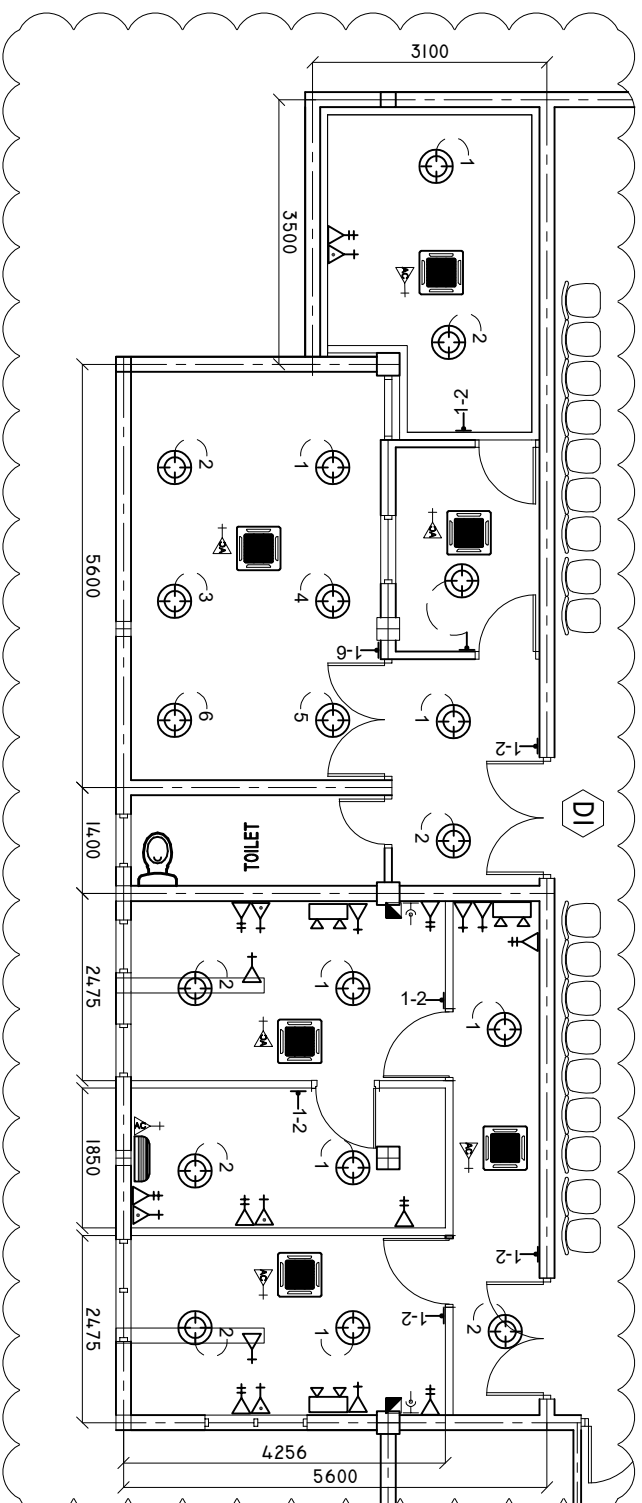

LEGEND

SYMBOL	DESCRIPTION
	LED BULB WITH 150MM DOWN LIGHT
	1 x 13 AMP SOCKET OUTLET (FLOOR MOUNT)
	2 x 13 AMP SOCKET OUTLET (600MM ABOVE FFL)
	1 x 15 AMP SOCKET OUTLET (600MM ABOVE FFL)
	1 x 15 AMP AC SOCKET OUTLET (300MM BLW, CEILING)
	TWO GANG SWITCH
	ONE WAY SWITCH
	EMERGENCY LIGHT
	DISTRIBUTION BOARD (WALL EMBEDDED)
	TELEPHONE SOCKET
	NETWORK SOCKET
	1 x 13 AMP SOCKET OUTLET (200MM BELOW CEILING)
	AC OUTDOOR UNIT
	AC INDOOR UNIT, CEILING CASSETTE TYPE
	EARTH PIT
	AC WALL MOUNT UNIT

SHEET CONTENTS :

REVISION NOTES:

PROJECT:
 RENOVATION OF
 RADIOLOGY
 DEPARTMENT AT R.
 UGOOFAARU REGIONAL
 HOSPITAL

CLIENT:
 MINISTRY OF HEALTH

LOCATION:
 R . UGOOFAARU

CONTENTS: AS GIVEN

PROJECT MANAGER:

DESIGNER: ARIZ

CV/STR. ENGINEER:

SURVEYED BY: -

DRAWN BY: ARIZ

CHECKED BY:





DATE : FEBRUARY 2020


SHEET NO. : /



DOORS AND WINDOWS SCHEDULE

Scale 1:50

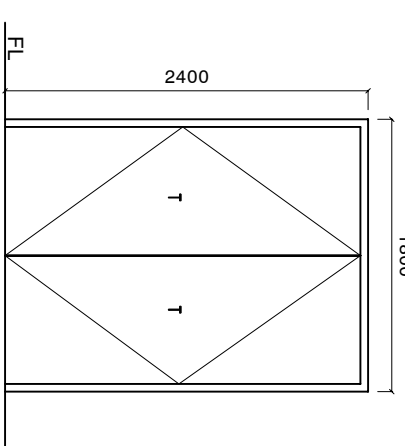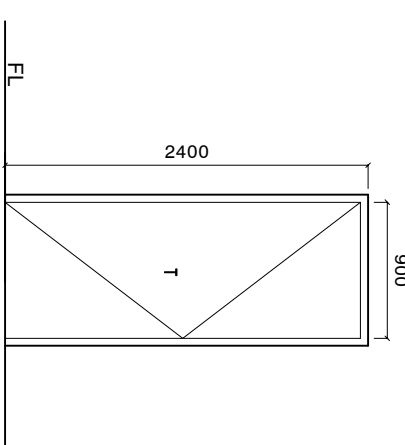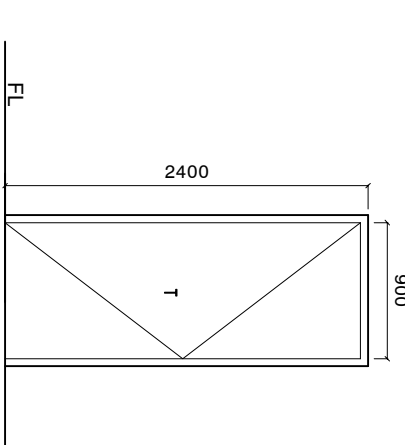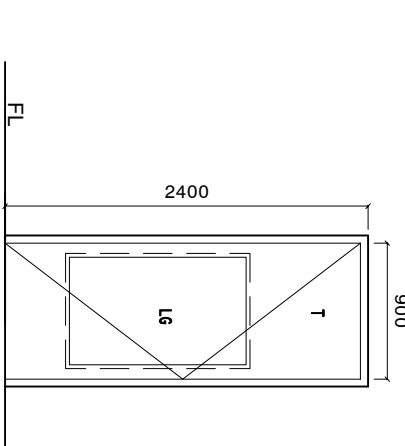SYMBOL	D1	D2	D3	D4
ELEVATION				
LOCATION	GROUND FLOOR	GROUND FLOOR	GROUND FLOOR	GROUND FLOOR
QUANTITY				
FRAME	SOLID TIMBER FRAME DOOR	SOLID TIMBER FRAME DOOR	SOLID TIMBER FRAME DOOR	SOLID TIMBER FRAME DOOR
PANEL	DECORATIVE SOLID TIMBER PANEL	TIMBER FRAME WITH 6MM PLY WOOD ON BOTH SIDE	TIMBER FRAME WITH 6MM PLY WOOD ON BOTH SIDE	TIMBER FRAME WITH 6MM PLY WOOD ON BOTH SIDE
FINISH	PAINT FINISH	PAINT FINISH	PAINT FINISH	PAINT FINISH
HINGE	STAINLESS STEEL	STAINLESS STEEL	STAINLESS STEEL	STAINLESS STEEL
LOCK	STATE MAKE	STATE MAKE	STATE MAKE	STATE MAKE
NOTE	ALL MEASUREMENTS TO BE CHECKED ON SITE	ALL MEASUREMENTS TO BE CHECKED ON SITE	ALL MEASUREMENTS TO BE CHECKED ON SITE	ALL MEASUREMENTS TO BE CHECKED ON SITE

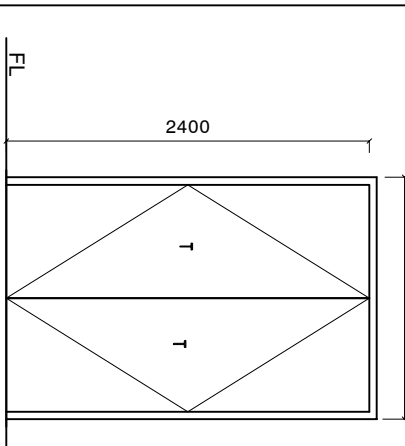SYMBOL	D5
ELEVATION	
LOCATION	GROUND FLOOR
QUANTITY	
FRAME	SOLID TIMBER FRAME DOOR
PANEL	DECORATIVE SOLID TIMBER PANEL
FINISH	PAINT FINISH
HINGE	STAINLESS STEEL
LOCK	STATE MAKE
NOTE	ALL MEASUREMENTS TO BE CHECKED ON SITE

NOTE:

ALL MEASUREMENTS TO BE CHECKED ON SITE BEFORE FABRICATION

T = PLYWOOD PANEL.

LG = LEAD GLASS (WILL BE PROVIDED BY CLIENT)

SHEET CONTENTS :

REVISION NOTES:

PROJECT:

RENOVATION OF
 RADIOLOGY
 DEPARTMENT AT R.
 UGOOFAARU REGIONAL
 HOSPITAL

CLIENT:

MINISTRY OF HEALTH

LOCATION:

R. UGOOFAARU

CONTENTS: AS GIVEN

PROJECT MANAGER:

DESIGNER: ARIZ

CV/STR. ENGINEER:

SURVEYED BY: -

DRAWN BY: ARIZ

CHECKED BY:


DATE : FEBRUARY 2020

SHEET NO. : /




TIE BEAM PLAN

SCALE: 1 : 100

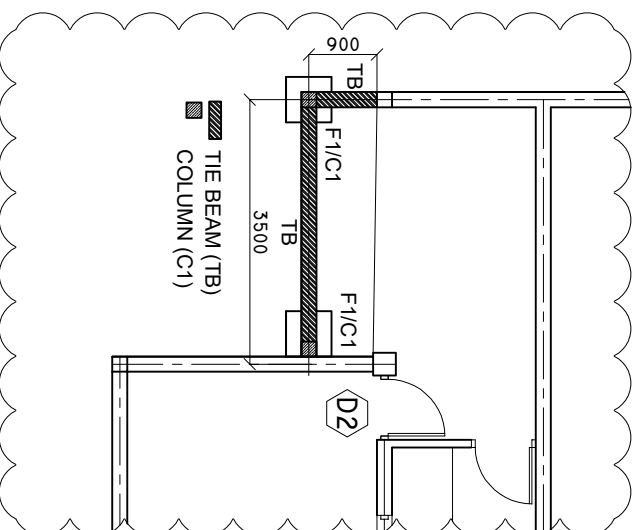


ROOF BEAM PLAN

SCALE: 1 : 100

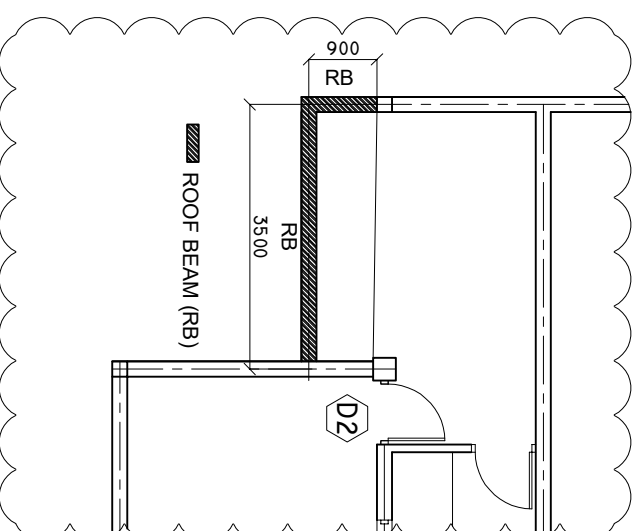

ROOF PLAN

SCALE: 1 : 100

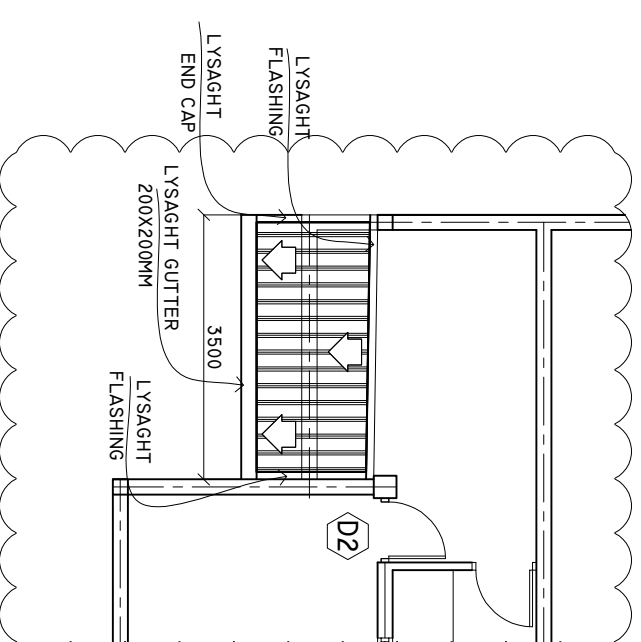

SHEET CONTENTS :

REVISION NOTES:

PROJECT:
RENOVATION OF
RADIOLOGY
DEPARTMENT AT R.
UGOOFAARU REGIONAL
HOSPITAL

CLIENT:

MINISTRY OF HEALTH

LOCATION:

R. UGOOFAARU

CONTENTS: AS GIVEN

PROJECT MANAGER:

DESIGNER: ARIZ

CV/STR. ENGINEER:

SURVEYED BY: -

DRAWN BY: ARIZ

CHECKED BY:

DATE : FEBRUARY 2020

SHEET NO. : /

