 


 
 


**LEGEND**

-  = 01 NOS NETWORK CABLE
-  = 01 GANG SOCKET
-  = 02 GANG SOCKET
-  = 03 GANG SOCKET
-  = 04 GANG SOCKET

**GROUND FLOOR ELECTRICAL PLAN**  
SCALE 1:100



GENERAL NOTES  
All representations are the property of FAHI DHIRIULHUN CORPORATION LTD, and may not be reproduced without written permission.


FIRST ISSUED DATE : \_\_\_\_\_ DRAWN : \_\_\_\_\_  
LOCATION  
WATERFRONT BUILDING  
PROJECT TITLE  
INTERIOR DESIGN CONCEPT

CLIENT  
- \_\_\_\_\_  
JOB NUMBER  
- \_\_\_\_\_  
DRAFTED BY  
- \_\_\_\_\_  
STAGE  
- \_\_\_\_\_

ARCHITECT  
- \_\_\_\_\_  
STRUCTURAL ENGINEER  
- \_\_\_\_\_  
ARCHITECTURAL CHECKED BY  
- \_\_\_\_\_  
DATE:  
STRUCTURAL CHECKED BY  
- \_\_\_\_\_  
DATE:  
- \_\_\_\_\_

NOTE

PAPER SIZE SCALE  
A3 AS GIVEN  
NO REVISION DETAIL DATE :  
NOTE 01  
DRAWING NUMBER  
A013 - A024  
revision **A**

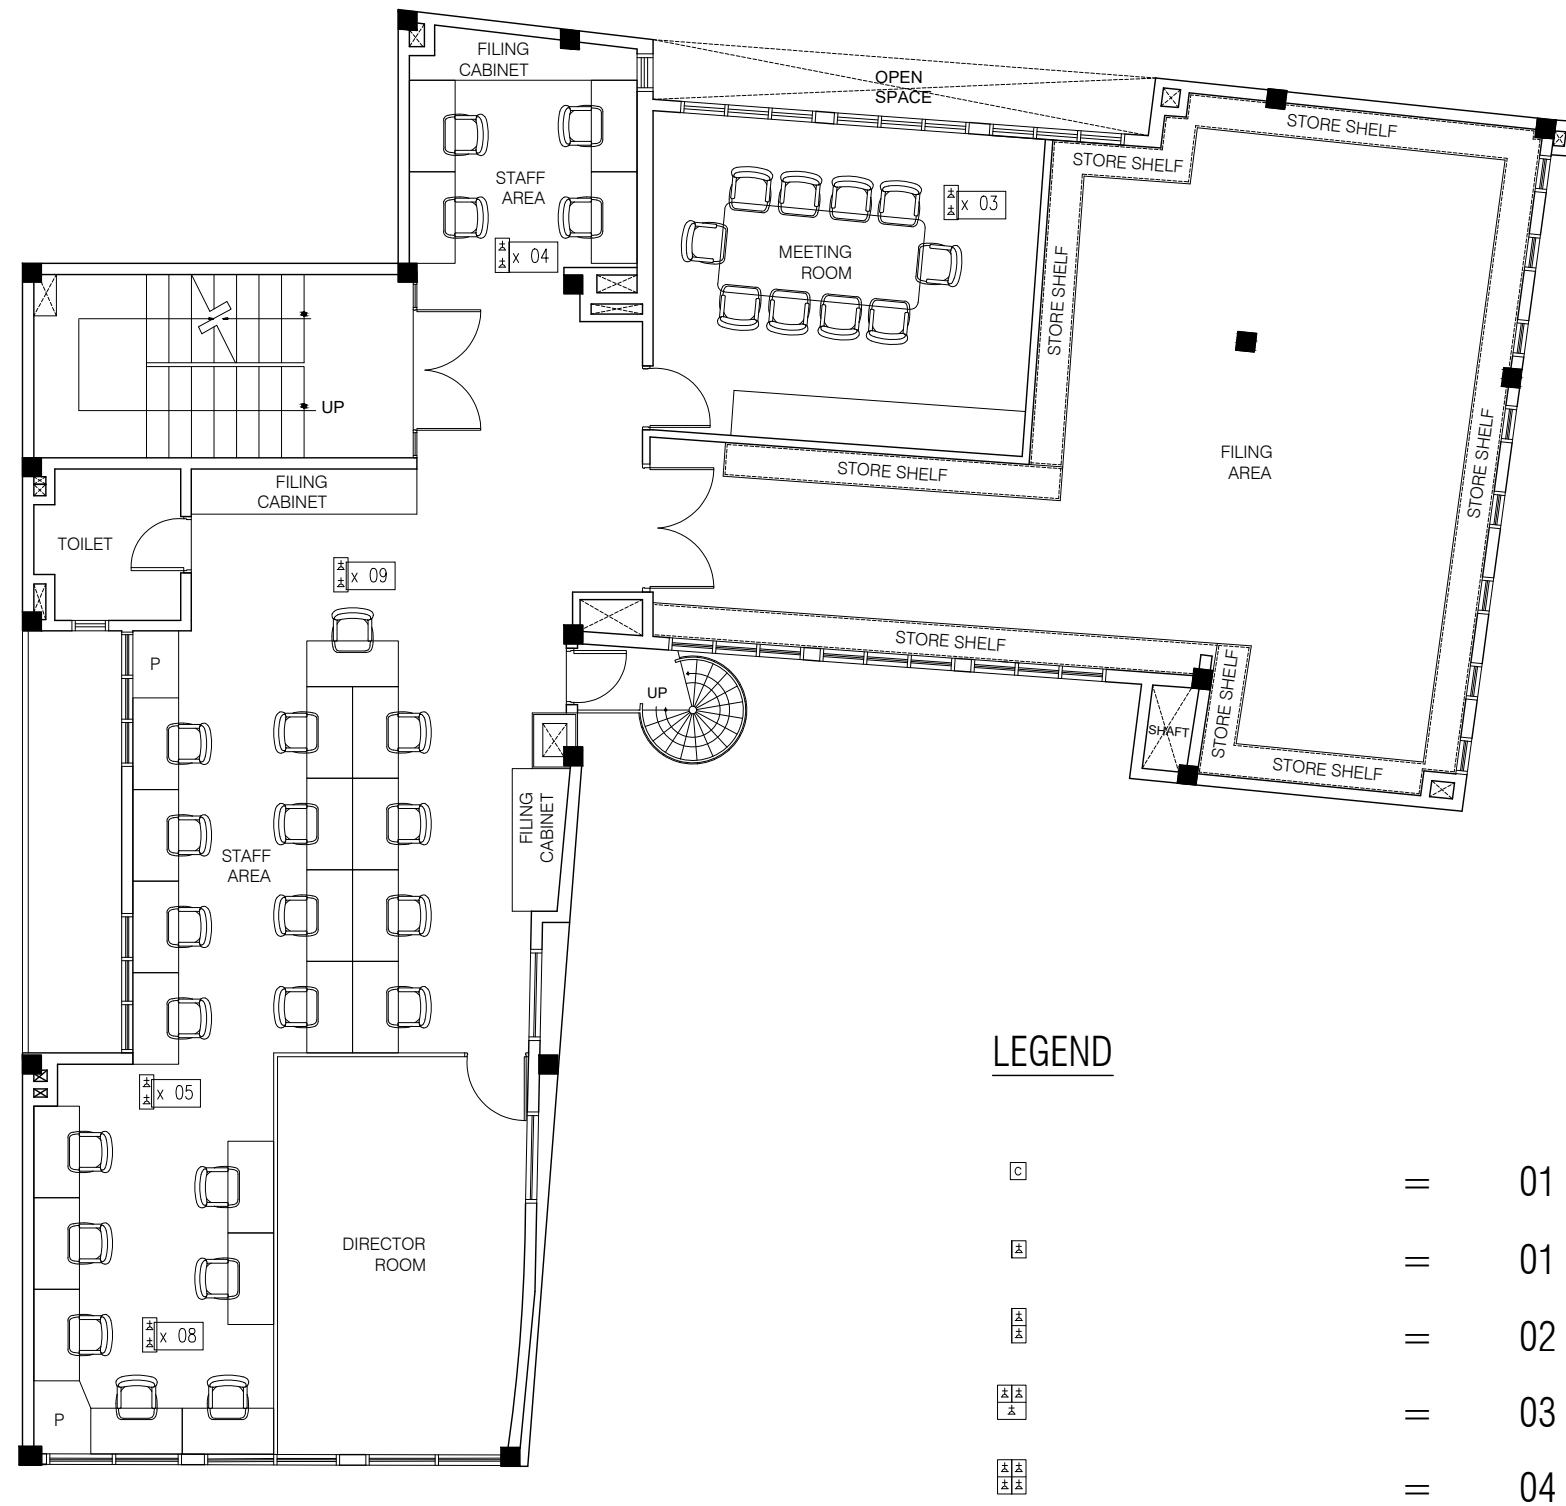

**FIRST FLOOR ELECTRICAL PLAN**  
SCALE 1:100



GENERAL NOTES  
All representations are the property of FAHI DHIRIULHUN CORPORATION LTD, and may not be reproduced without written permission.


FIRST ISSUED DATE: \_\_\_\_\_ DRAWN: \_\_\_\_\_  
LOCATION  
WATERFRONT BUILDING  
PROJECT TITLE  
INTERIOR DESIGN CONCEPT

CLIENT  
-  
JOB NUMBER  
-  
DRAFTED BY  
-  
STAGE  
-  
DATE: \_\_\_\_\_

 


 
 
ARCHITECT  
-  
STRUCTURAL ENGINEER  
-  
ARCHITECTURAL CHECKED BY  
-  
DATE: \_\_\_\_\_  
STRUCTURAL CHECKED BY  
-  
DATE: \_\_\_\_\_

NOTE

 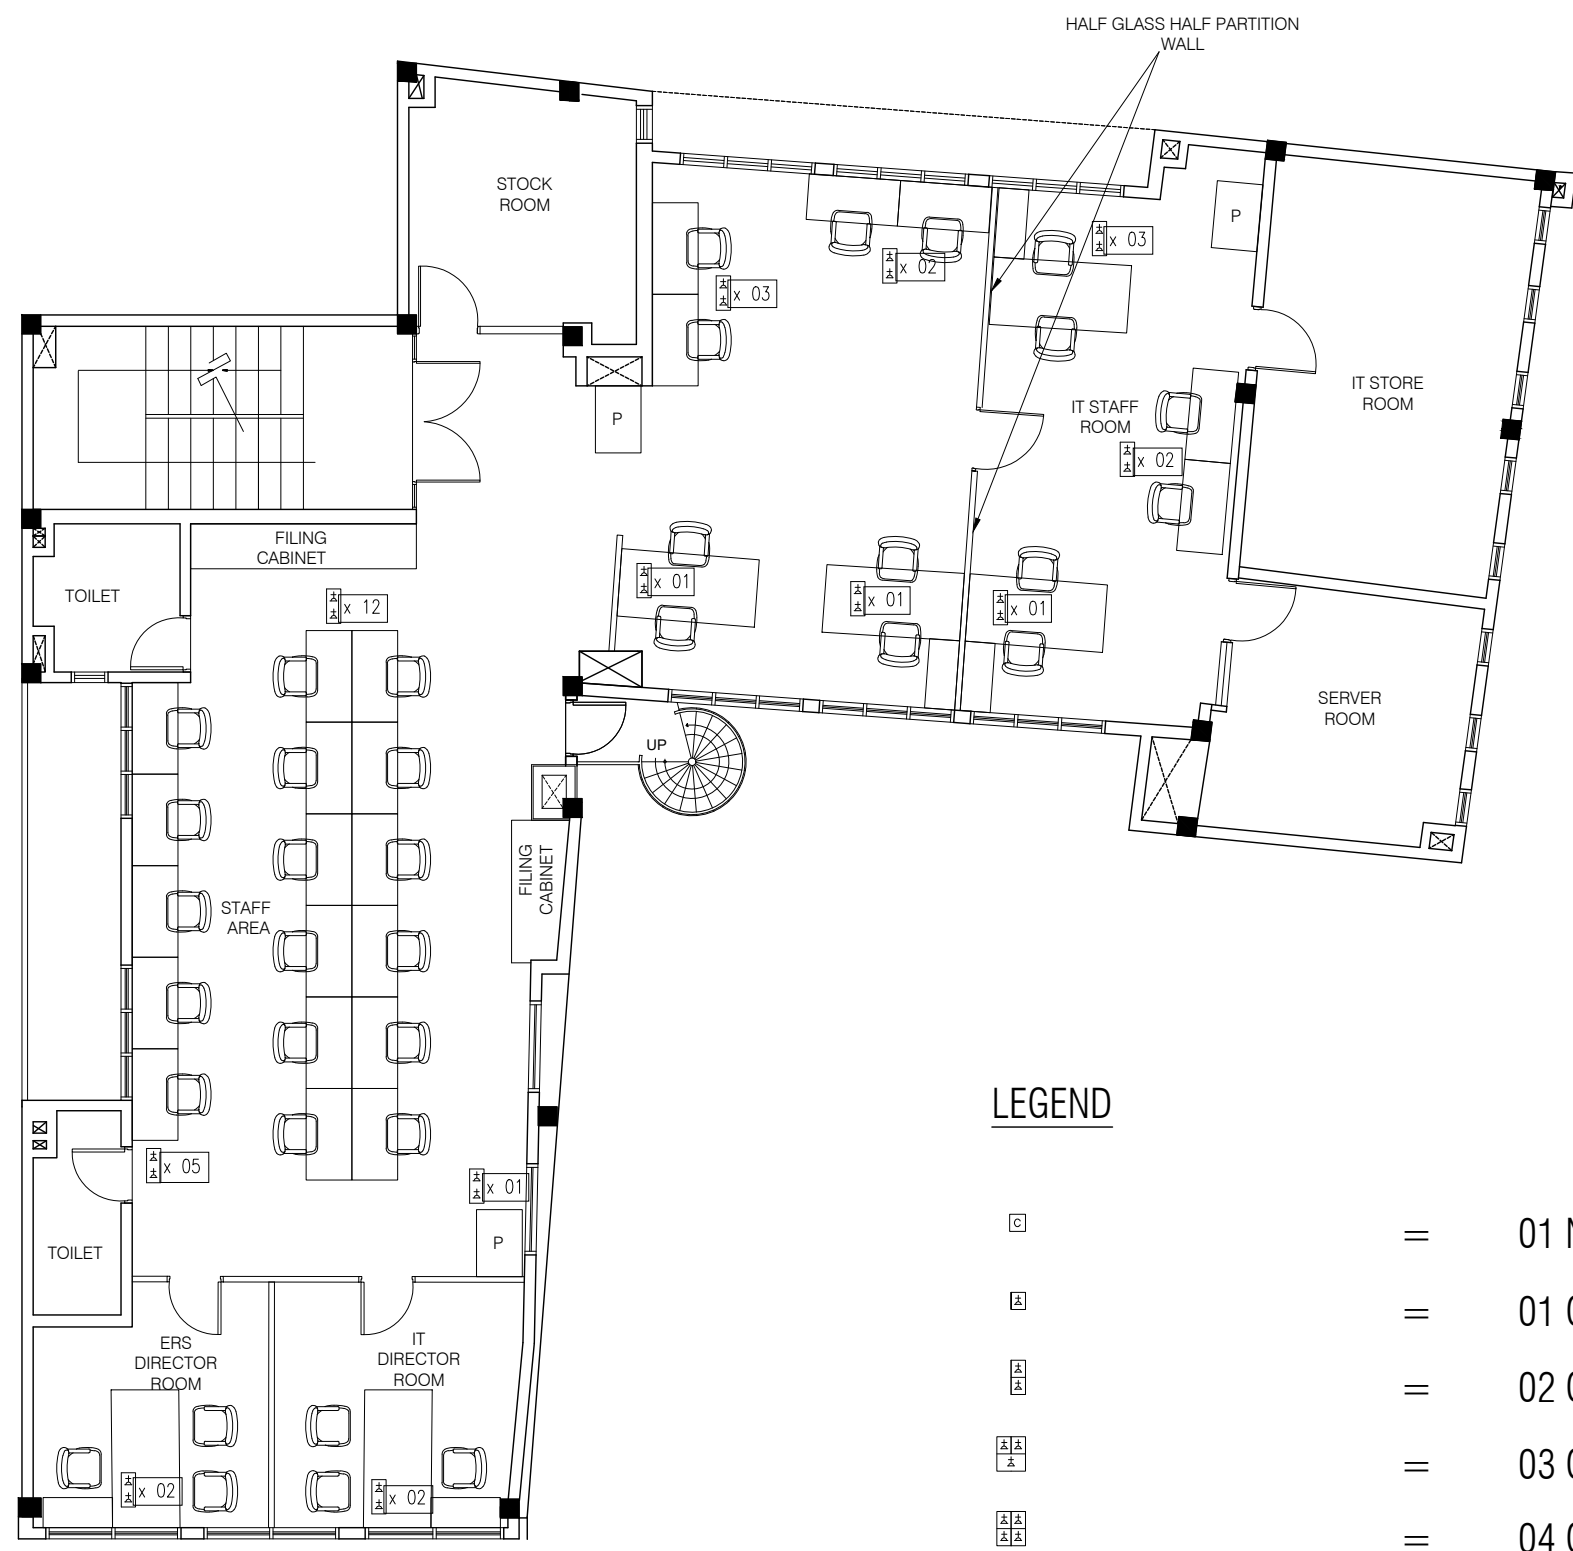
PAPER SIZE SCALE  
A3 AS GIVEN  
NO REVISION DETAIL DATE :  
NOTE 01  
DRAWING NUMBER  
A014 - A024  
revision A



**LEGEND**

-  = 01 NOS NETWORK CABLE
-  = 01 GANG SOCKET
-  = 02 GANG SOCKET
-  = 03 GANG SOCKET
-  = 04 GANG SOCKET

**SECOND FLOOR ELECTRICAL PLAN**  
SCALE 1:100



**GENERAL NOTES**  
All representations are the property of FAHI DHIRIULHUN CORPORATION LTD, and may not be reproduced without written permission.


FIRST ISSUED DATE: \_\_\_\_\_ DRAWN: \_\_\_\_\_  
LOCATION  
WATERFRONT BUILDING  
PROJECT TITLE  
INTERIOR DESIGN CONCEPT

CLIENT  
-  
JOB NUMBER  
-  
DRAFTED BY  
-  
STAGE  
-

ARCHITECT  
-  
STRUCTURAL ENGINEER  
-  
ARCHITECTURAL CHECKED BY  
-  
DATE:  
STRUCTURAL CHECKED BY  
-  
DATE:

NOTE

 
PAPER SIZE SCALE  
A3 AS GIVEN  
NO REVISION DETAIL DATE:  
NOTE 01  
DRAWING NUMBER  
A015 - A024  
revision A

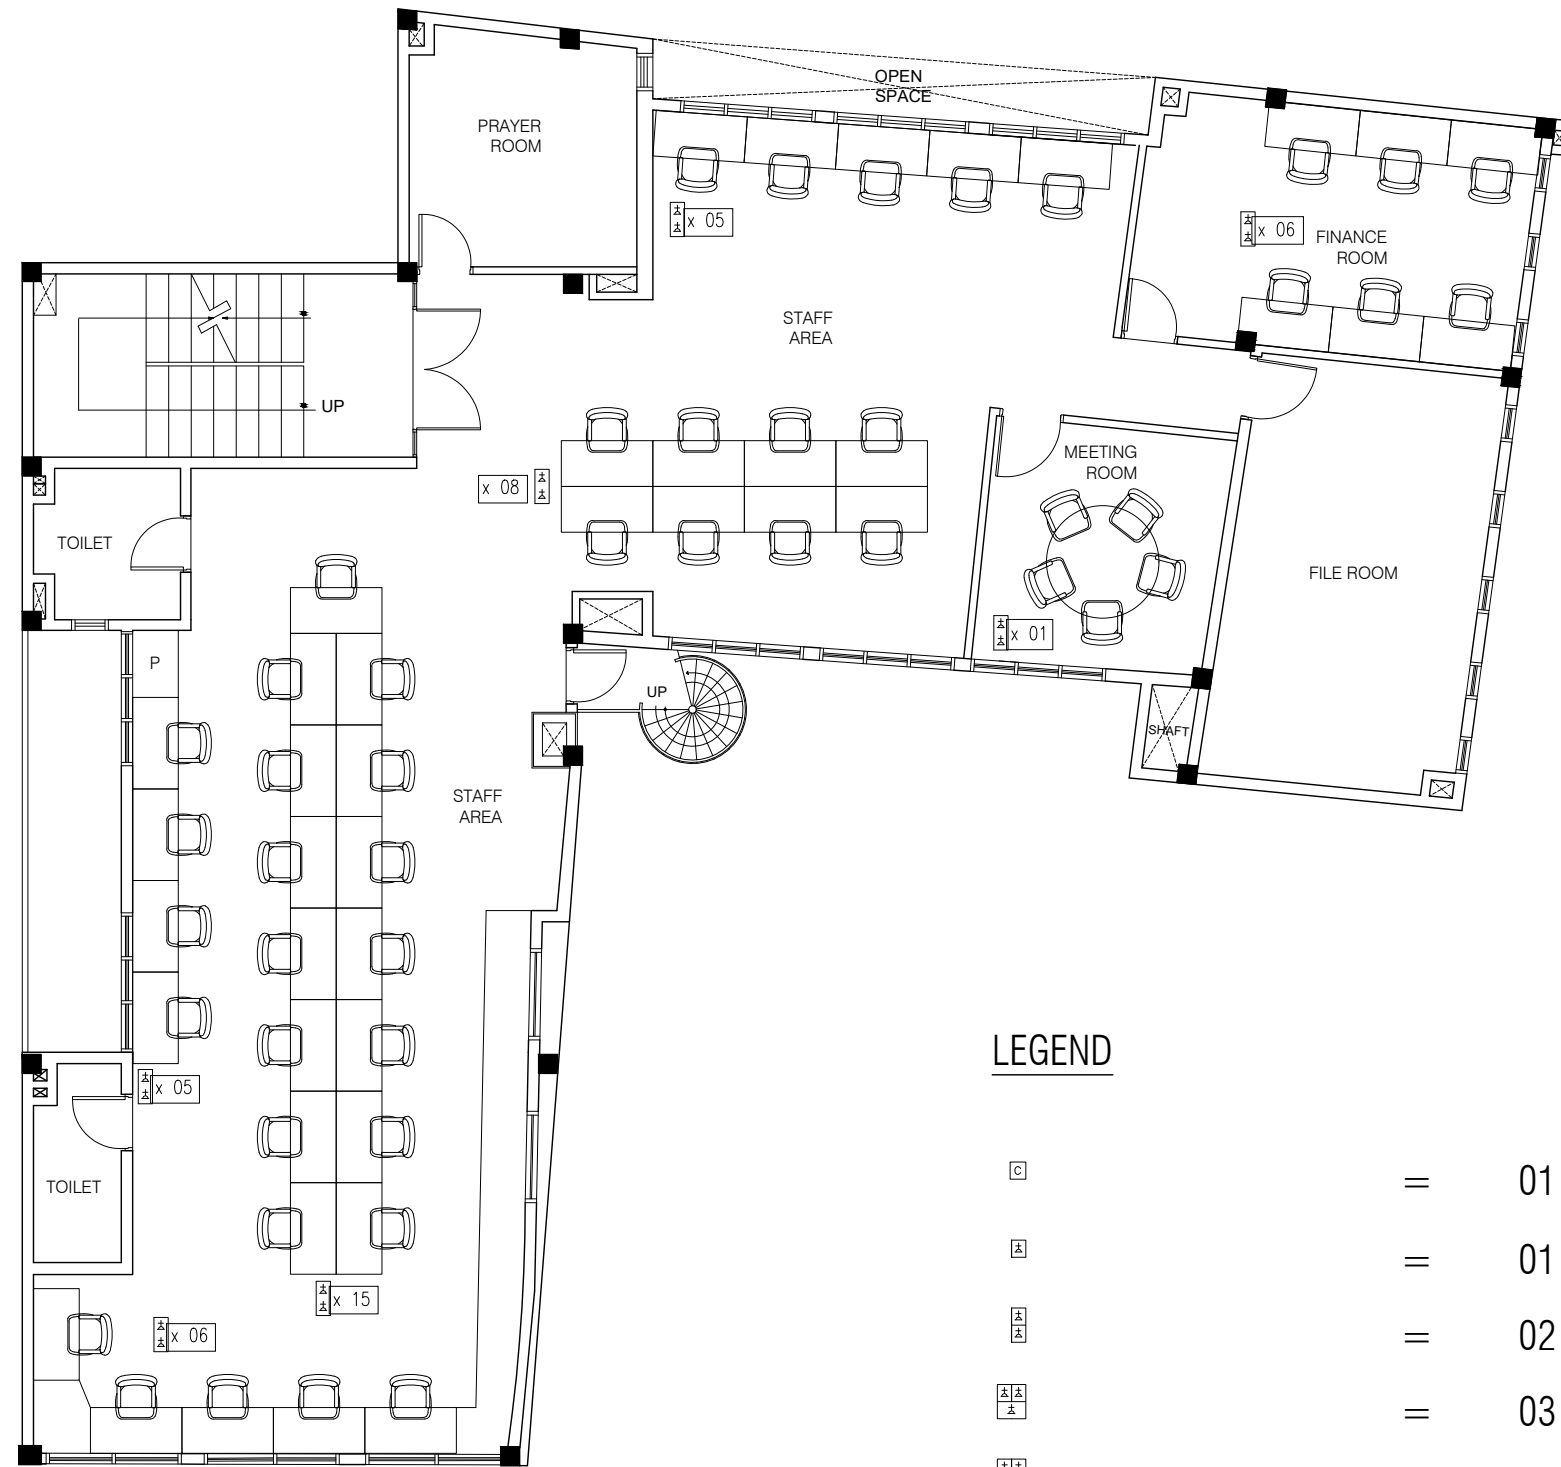

**LEGEND**

- = 01 NOS NETWORK CABLE
- = 01 GANG SOCKET
- = 02 GANG SOCKET
- = 03 GANG SOCKET
- = 04 GANG SOCKET

**THIRD FLOOR ELECTRICAL PLAN**  
SCALE 1:100



GENERAL NOTES  
All representations are the property of FAHI DHIRULHUN CORPORATION LTD, and may not be reproduced without written permission.

FIRST ISSUED DATE: \_\_\_\_\_ DRAWN: \_\_\_\_\_  
LOCATION  
WATERFRONT BUILDING  
PROJECT TITLE  
INTERIOR DESIGN CONCEPT

CLIENT  
-  
JOB NUMBER  
-  
DRAFTED BY  
-  
STAGE  
-

ARCHITECT  
-  
STRUCTURAL ENGINEER  
-  
ARCHITECTURAL CHECKED BY  
-  
DATE:  
STRUCTURAL CHECKED BY  
-  
DATE:

NOTE

PAPER SIZE SCALE  
A3 AS GIVEN  
NO REVISION DETAIL DATE:  
NOTE 01

DRAWING NUMBER  
A016 - A024

revision **A**