


LOCATION PLAN

SCALE: 1 : 100

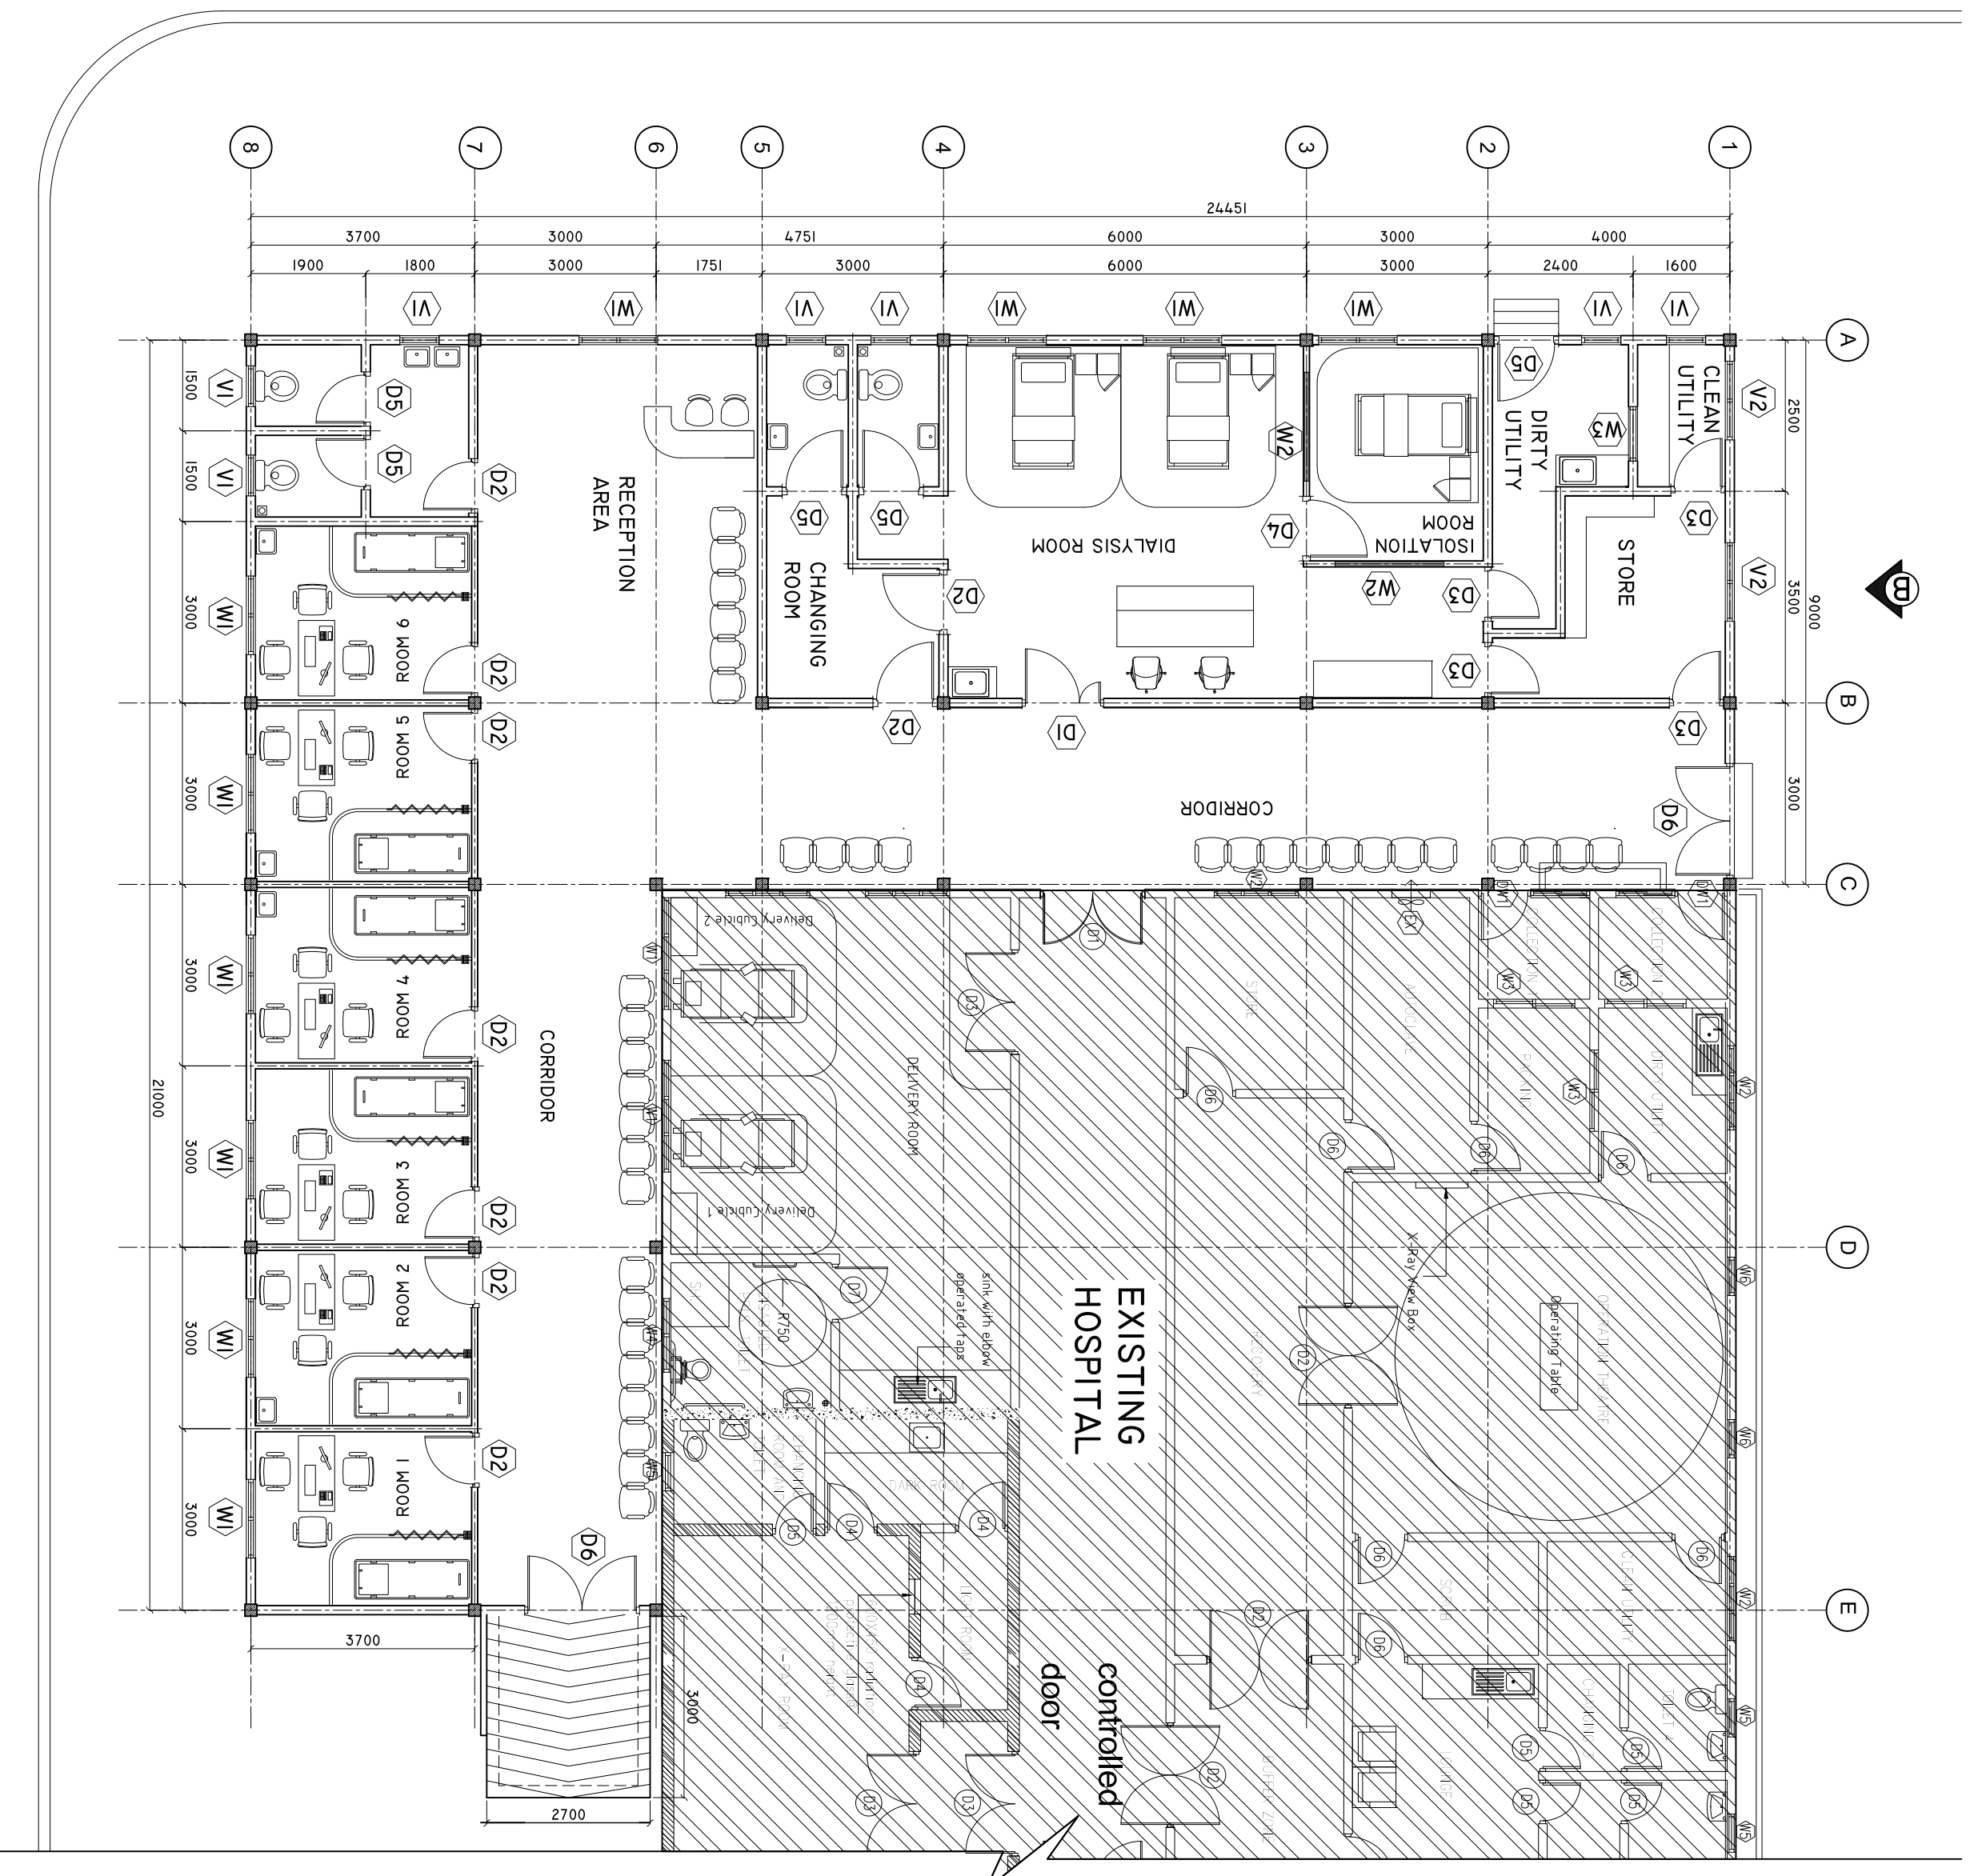

SHEET CONTENTS :

REVISION NOTES:

PROJECT:
CONSTRUCTION OF
EXTENSION WING

CLIENT:
MINISTRY OF HEALTH

LOCATION:
B. EYDAHUSHI

CONTENTS: AS GIVEN

PROJECT MANAGER:
DESIGNER: ARIZ

CIVIL/STR. ENGINEER:
SUPERVED BY: -


DRAWN BY: ARIZ
CHECKED BY:

DATE: JAN 2020 /
SHEET NO. : /

PAPER SIZE: A2

SITE PLAN

SCALE: 1 : 100

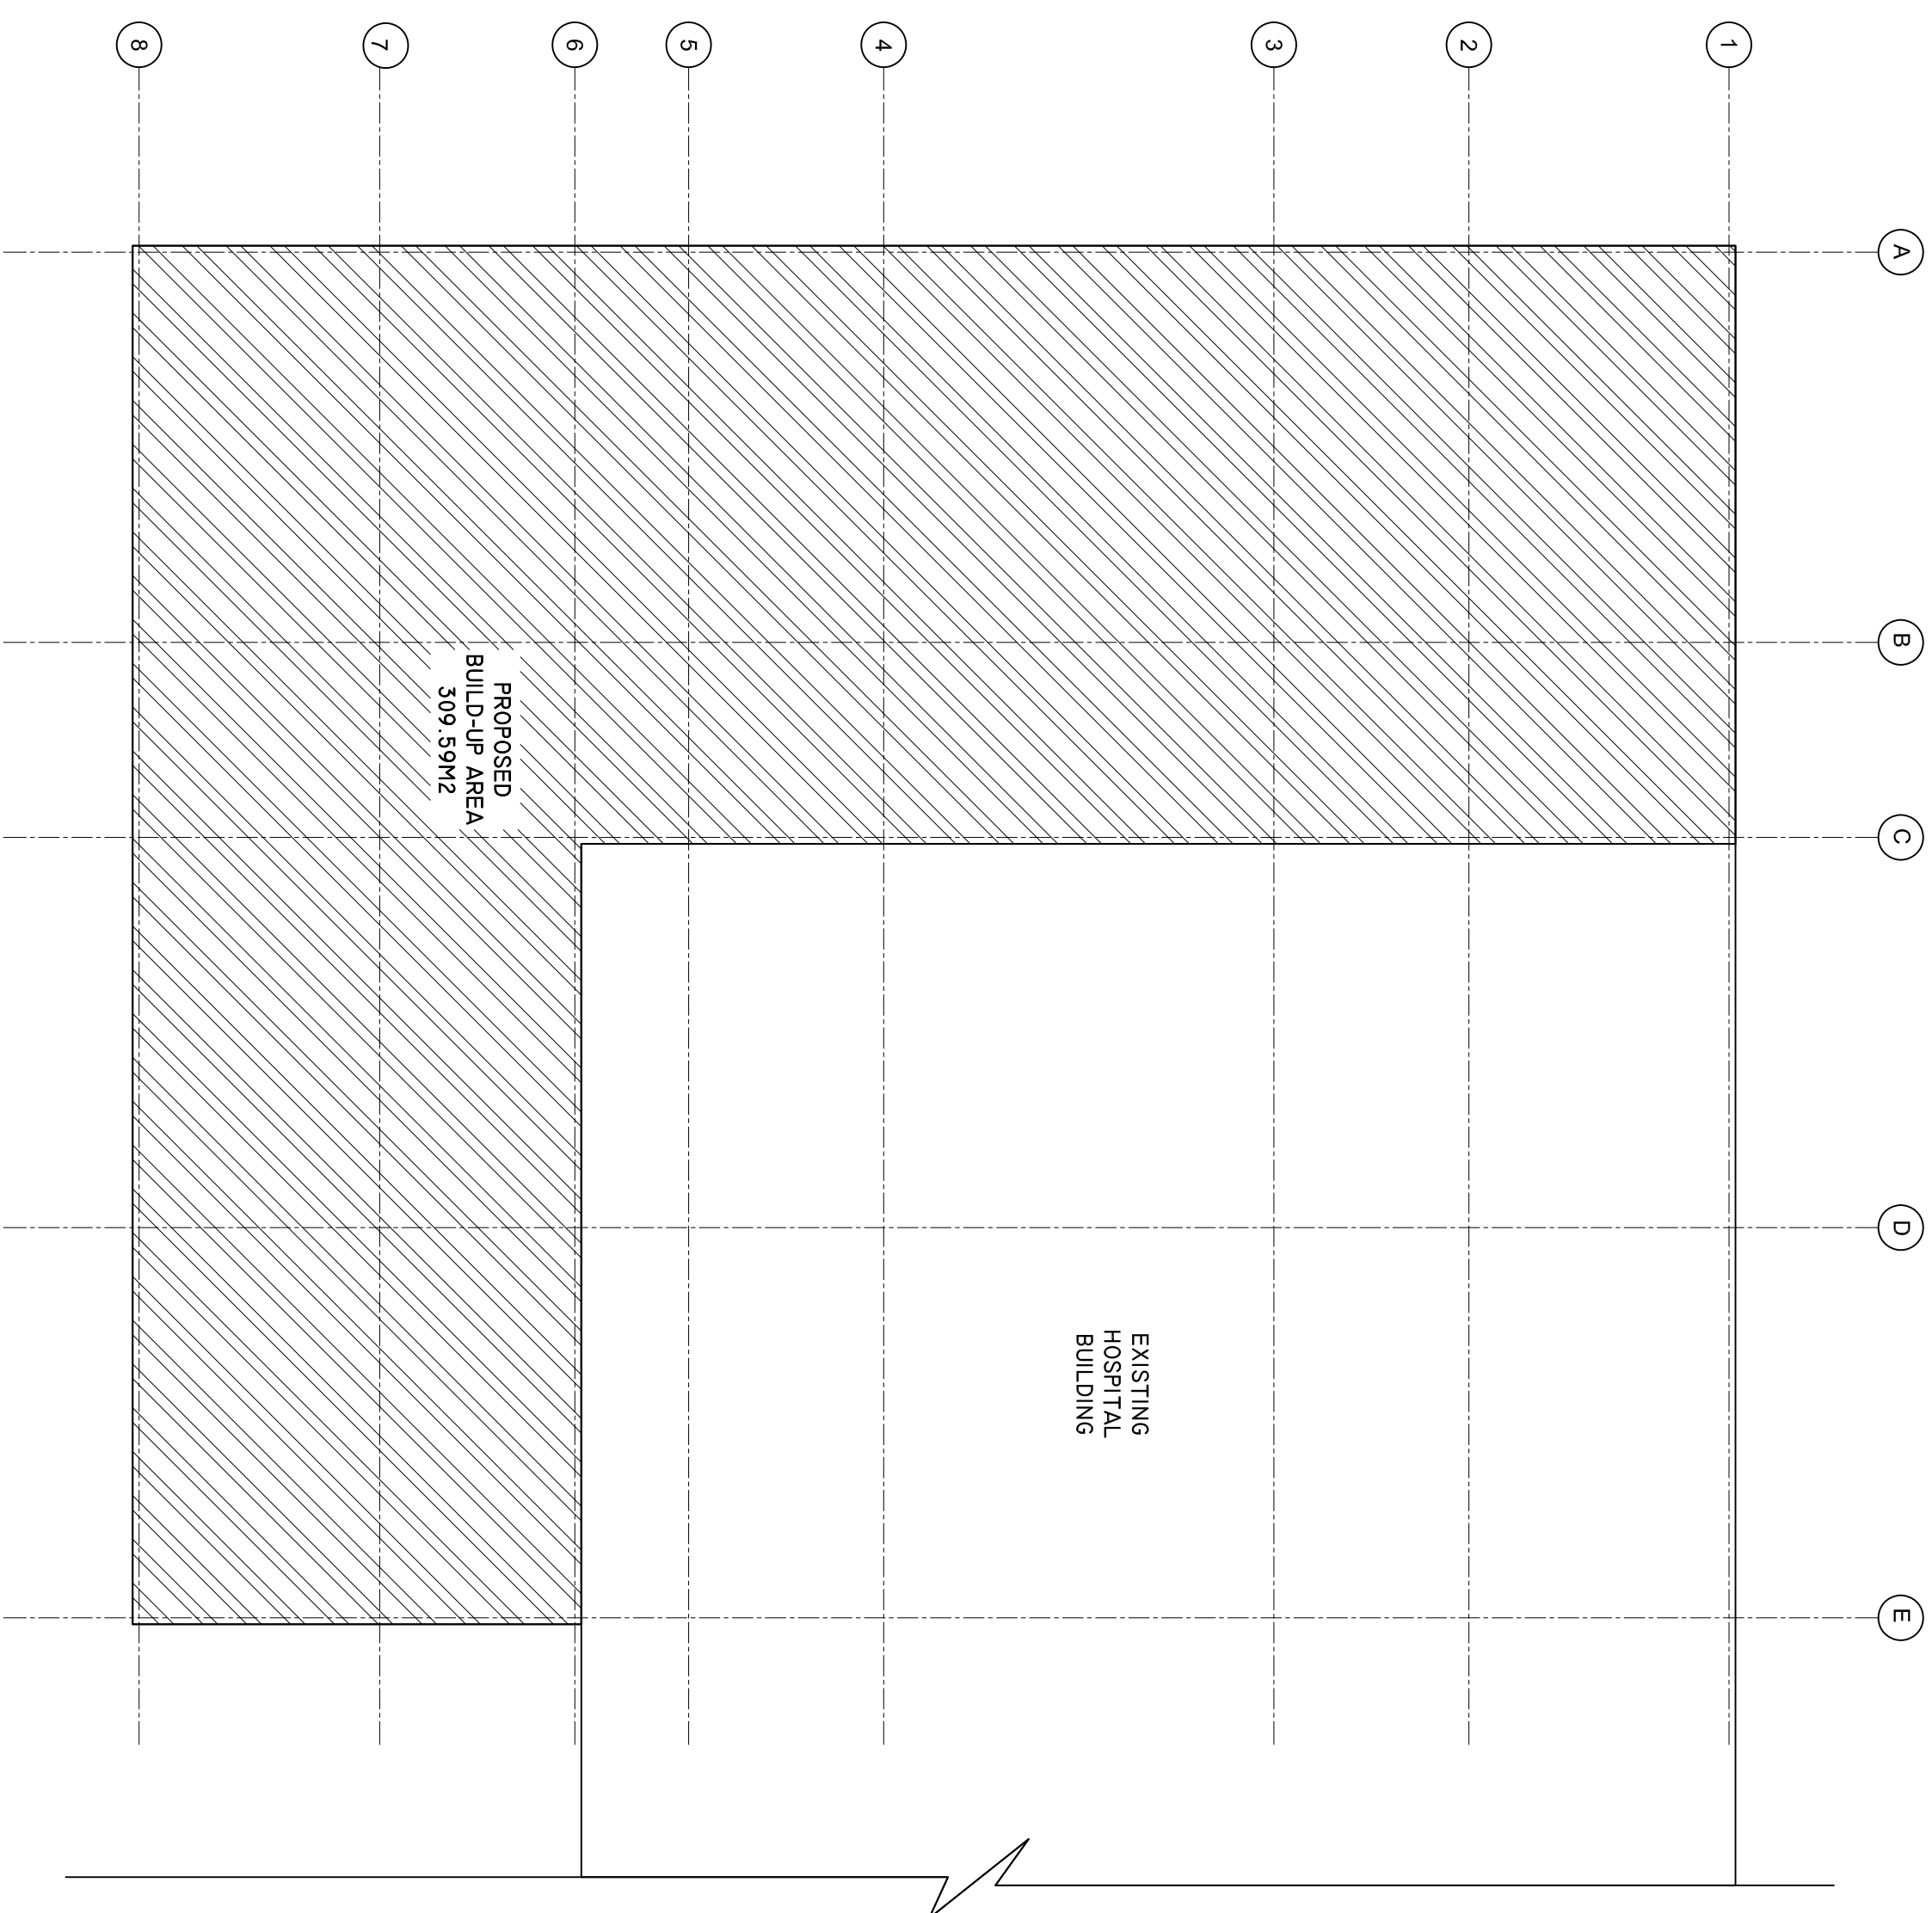

SHEET CONTENTS :

PROJECT :
CONSTRUCTION OF
EXTENSION WING

CLIENT:
MINISTRY OF HEALTH

LOCATION:
B. EYDAFUSHI


CONTENTS: AS GIVEN

PROJECT MANAGER:
DESIGNER: ARIZ
CIVIL/STR. ENGINEER
SUPERVED BY: -
DRAWN BY: ARIZ
CHECKED BY: -
DATE : JAN 2020 /

SHEET NO. : /

PAPER SIZE: A2

FLOOR PLAN
SCALE: 1 : 100

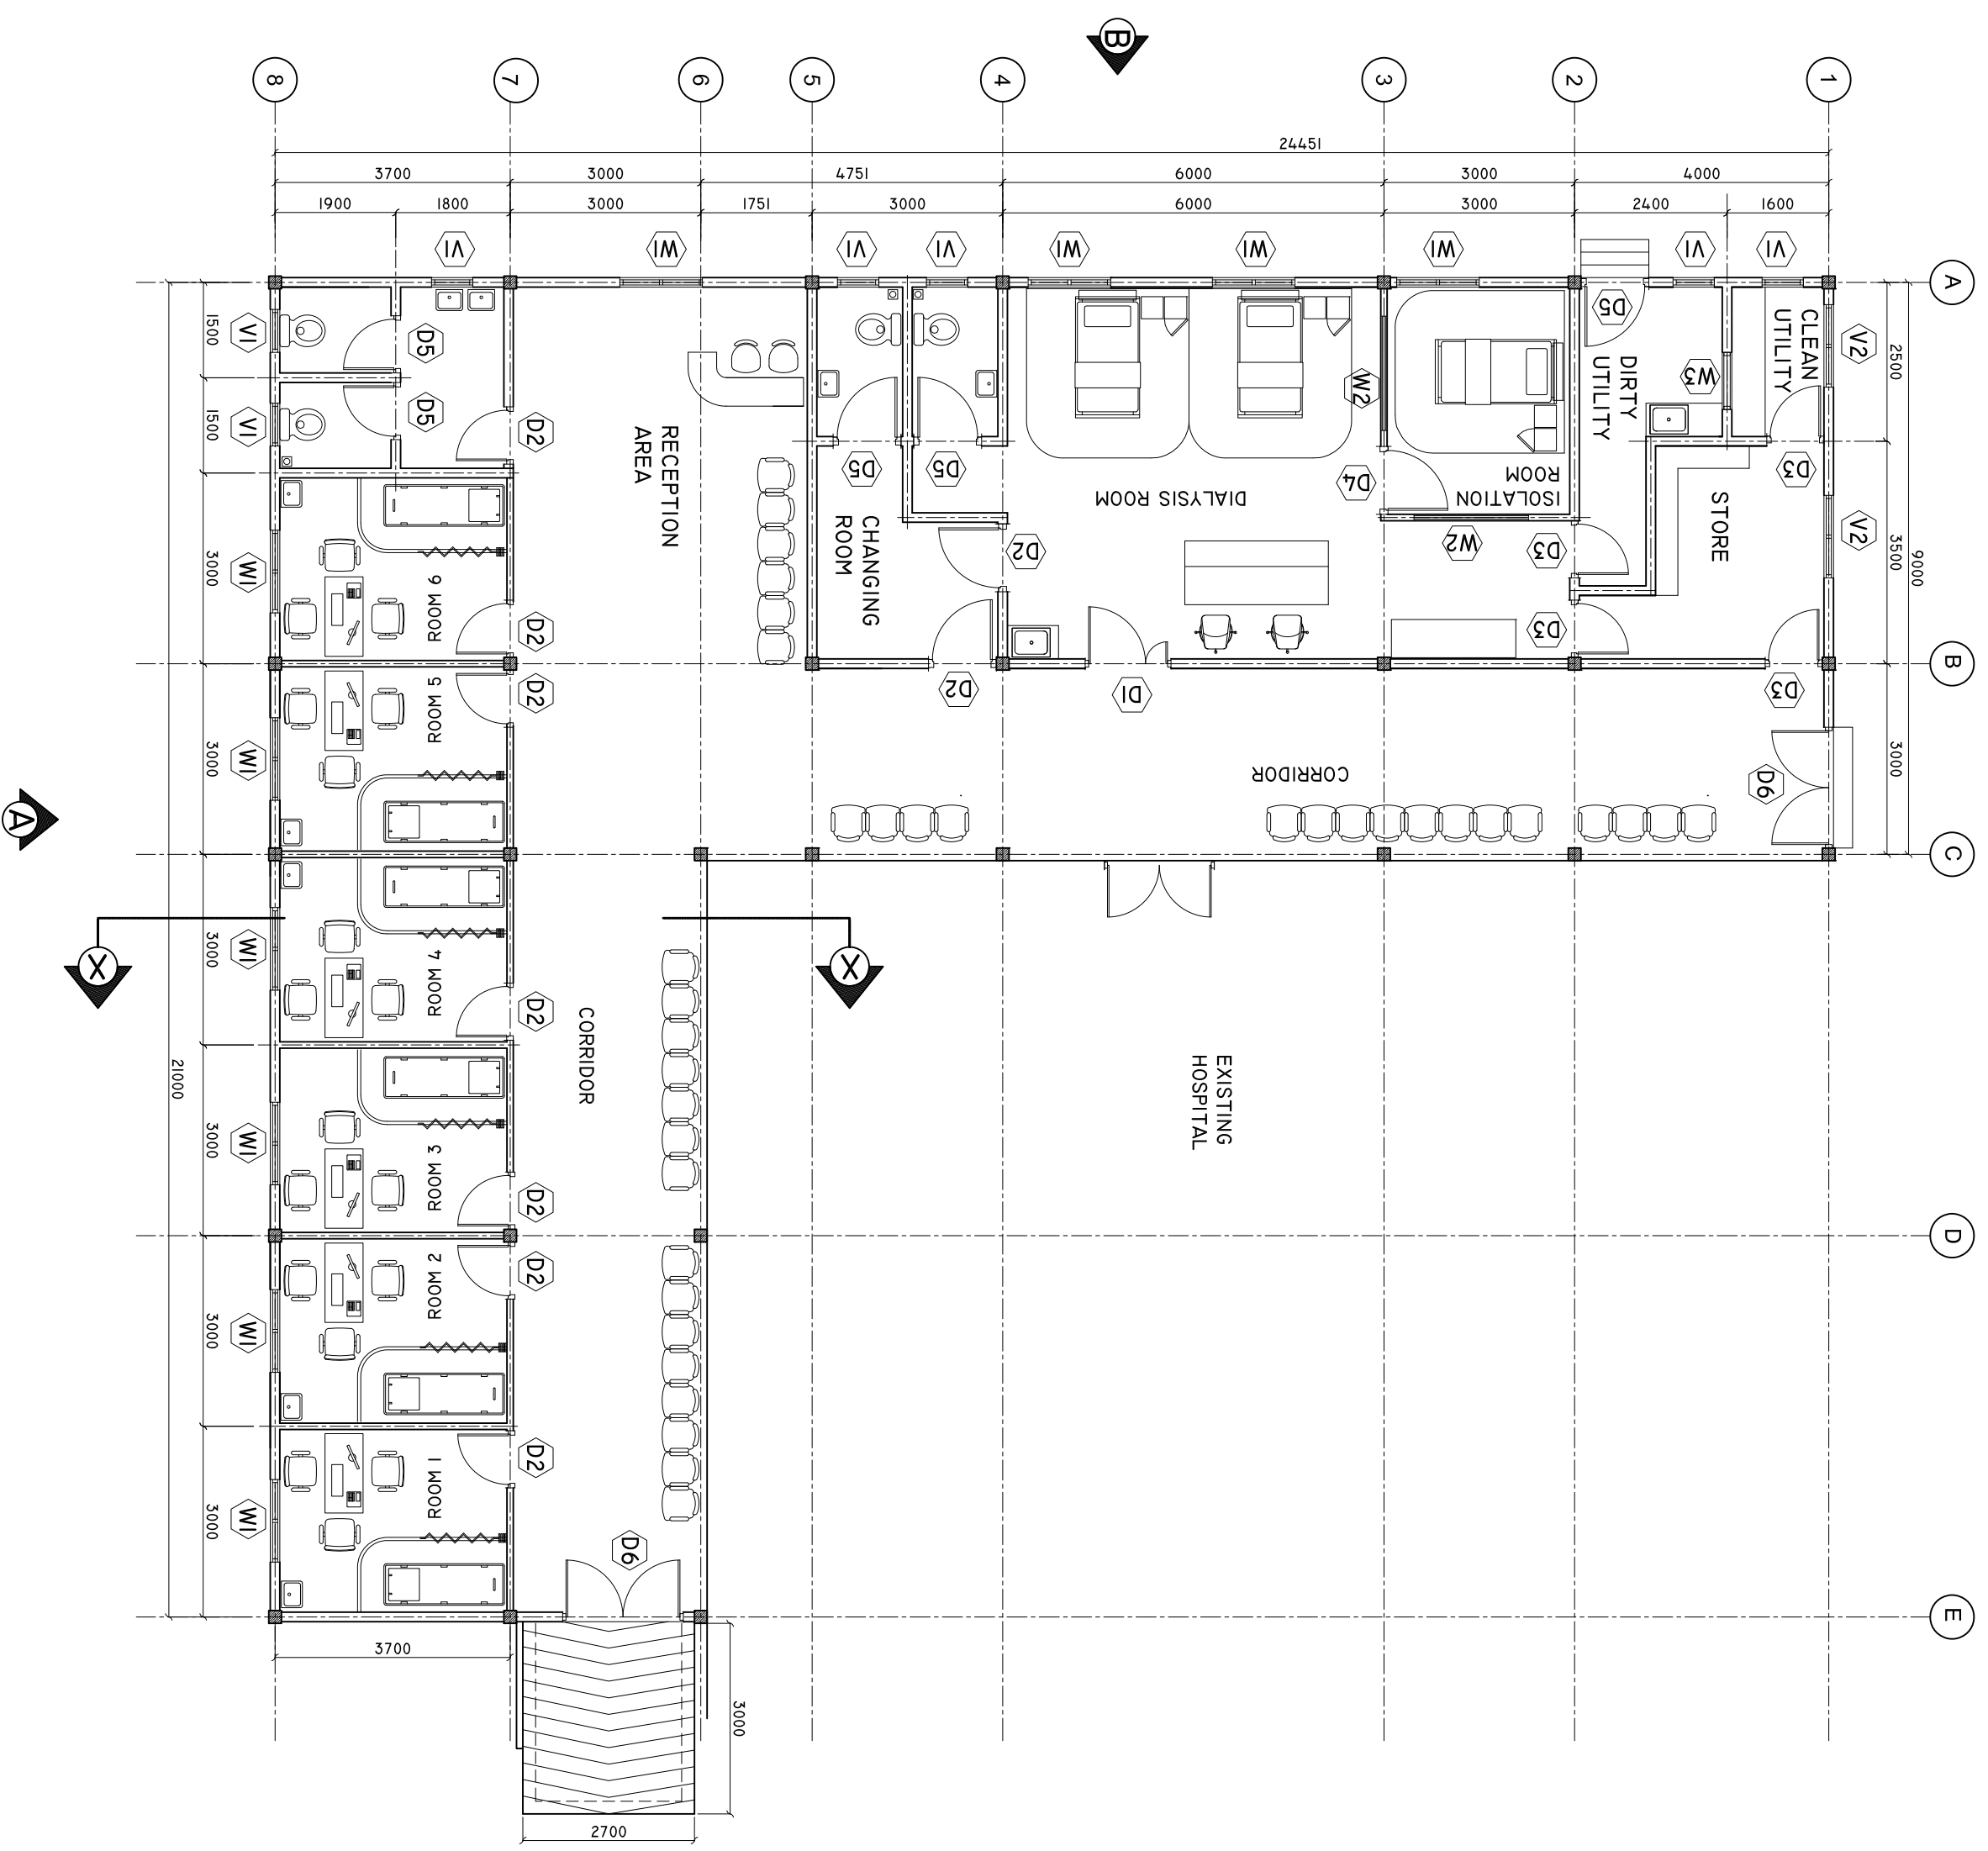

SHEET CONTENTS :

PROJECT :
CONSTRUCTION OF
EXTENSION WING

CLIENT :
MINISTRY OF HEALTH

LOCATION :
B. EYDAHUSHI

CONTENTS : AS GIVEN

PROJECT MANAGER :
DESIGNER : ARIZ

CIVIL/STR. ENGINEER :
SUPERVISED BY : -

DRAWN BY : ARIZ

CHECKED BY : -

DATE : JAN 2020

SHEET NO. : /

PAPER SIZE : A2

JADWIN CONSULTANTS
Ministry of Health
Roskeene Building
Suva, Fiji
TEL: 332 8887, FAX: 3328899

DOORS AND WINDOWS SCHEDULE

Scale 1:50

SYMBOL	D1	D2	D3	D4	D5
LOCATION:	GROUND FLOOR	GROUND FLOOR	GROUND FLOOR	GROUND FLOOR	GROUND FLOOR
QUANTITY:	00 nos.	00 nos.	00 nos.	00 nos.	00 nos.
FRAME:	TIMBER FRAME DOOR	TIMBER FRAME DOOR	TIMBER FRAME DOOR	TIMBER FRAME DOOR	TIMBER FRAME DOOR
PANEL:	TIMBER PANEL	TIMBER PANEL	TIMBER PANEL	TIMBER PANEL	TIMBER PANEL
FINISH:	PAINT FINISH	PAINT FINISH	PAINT FINISH	PAINT FINISH	PAINT FINISH
HINGE:	STAINLESS STEEL	STAINLESS STEEL	STAINLESS STEEL	STAINLESS STEEL	STAINLESS STEEL
LOCK:	STATE MAKE	STATE MAKE	STATE MAKE	STATE MAKE	STATE MAKE
NOTE:	ALL MEASUREMENTS TO BE CHECKED ON SITE	ALL MEASUREMENTS TO BE CHECKED ON SITE	ALL MEASUREMENTS TO BE CHECKED ON SITE	ALL MEASUREMENTS TO BE CHECKED ON SITE	ALL MEASUREMENTS TO BE CHECKED ON SITE

SYMBOL	D6	W1	W2	V1	V2
LOCATION:	GROUND FLOOR	GROUND FLOOR	GROUND FLOOR	GROUND FLOOR	GROUND FLOOR
QUANTITY:	00 nos.	00 nos.	00 nos.	06 nos.	06 nos.
FRAME:	ALUMINIUM FRAME DOOR	ALUMINIUM FRAME DOOR	ALUMINIUM FRAME DOOR	ALUMINIUM FRAME DOOR	ALUMINIUM FRAME DOOR
PANEL:	ALUMINIUM 60-80 MICRON POWDER COATING	ALUMINIUM 60-80 MICRON POWDER COATING	ALUMINIUM 60-80 MICRON POWDER COATING	ALUMINIUM 60-80 MICRON POWDER COATING	ALUMINIUM 60-80 MICRON POWDER COATING
FINISH:	ALUMINIUM IN 60-80 MICRON POWDER COATING	ALUMINIUM IN 60-80 MICRON POWDER COATING	ALUMINIUM IN 60-80 MICRON POWDER COATING	ALUMINIUM IN 60-80 MICRON POWDER COATING	ALUMINIUM IN 60-80 MICRON POWDER COATING
HINGE:	STAINLESS STEEL	STAINLESS STEEL	STAINLESS STEEL	STAINLESS STEEL	STAINLESS STEEL
LOCK:	STATE MAKE	STATE MAKE	STATE MAKE	STATE MAKE	STATE MAKE
NOTE:	ALL MEASUREMENTS TO BE CHECKED ON SITE	ALL MEASUREMENTS TO BE CHECKED ON SITE	ALL MEASUREMENTS TO BE CHECKED ON SITE	ALL MEASUREMENTS TO BE CHECKED ON SITE	ALL MEASUREMENTS TO BE CHECKED ON SITE

NOTE:
 PROVIDE RC LINTEL ABOVE ALL DOOR/WINDOW/VENTILATOR UNITS
 NOT FIXED TO BEAMS
 AND PROVIDE RC SILL BEAMS UNDER ALL WINDOW UNITS
 ALL TIMBER DOORS TO BE MADE OF TIMBER PUTTY SMOOTHED AND FINISHED WITH ENAMEL PAINT AS SPECIFIED

GL= 6MM TINTED LAMINATED GLASS
 CL= 5 CLADDING SHEET, WHITE POWDER COATED ON BOTH SIDE DOUBLE LAYER
 T= TIMBER DOOR, TIMBER DOOR FRAME WITH BORDER.
 5MM TICK PLYWOOD WITH TIMBER FRAMED DOOR PANEL.
 ALL THE ALUMINIUM PROFILE MUST BE MINIMUM 2MM THICK.

SHEET CONTENTS :

PROJECT: CONSTRUCTION OF EXTENSION WING

CLIENT: MINISTRY OF HEALTH

LOCATION: B. EYHAHUSHI

CONTENTS: AS GIVEN

PROJECT MANAGER: DESIGNER: ARIZ

CIVIL/STR. ENGINEER: SUPERVED BY: -

DRAWN BY: ARIZ

CHECKED BY: -

DATE: JAN 2020


SHEET NO. : /

PAPER SIZE: A2

40XIN/01170N
 Ministry of Health
 Robson Building
 Suva Major
 Tel: 332 8887 Fax: 3328899

ROOF BEAM PLAN

SCALE: 1 : 100

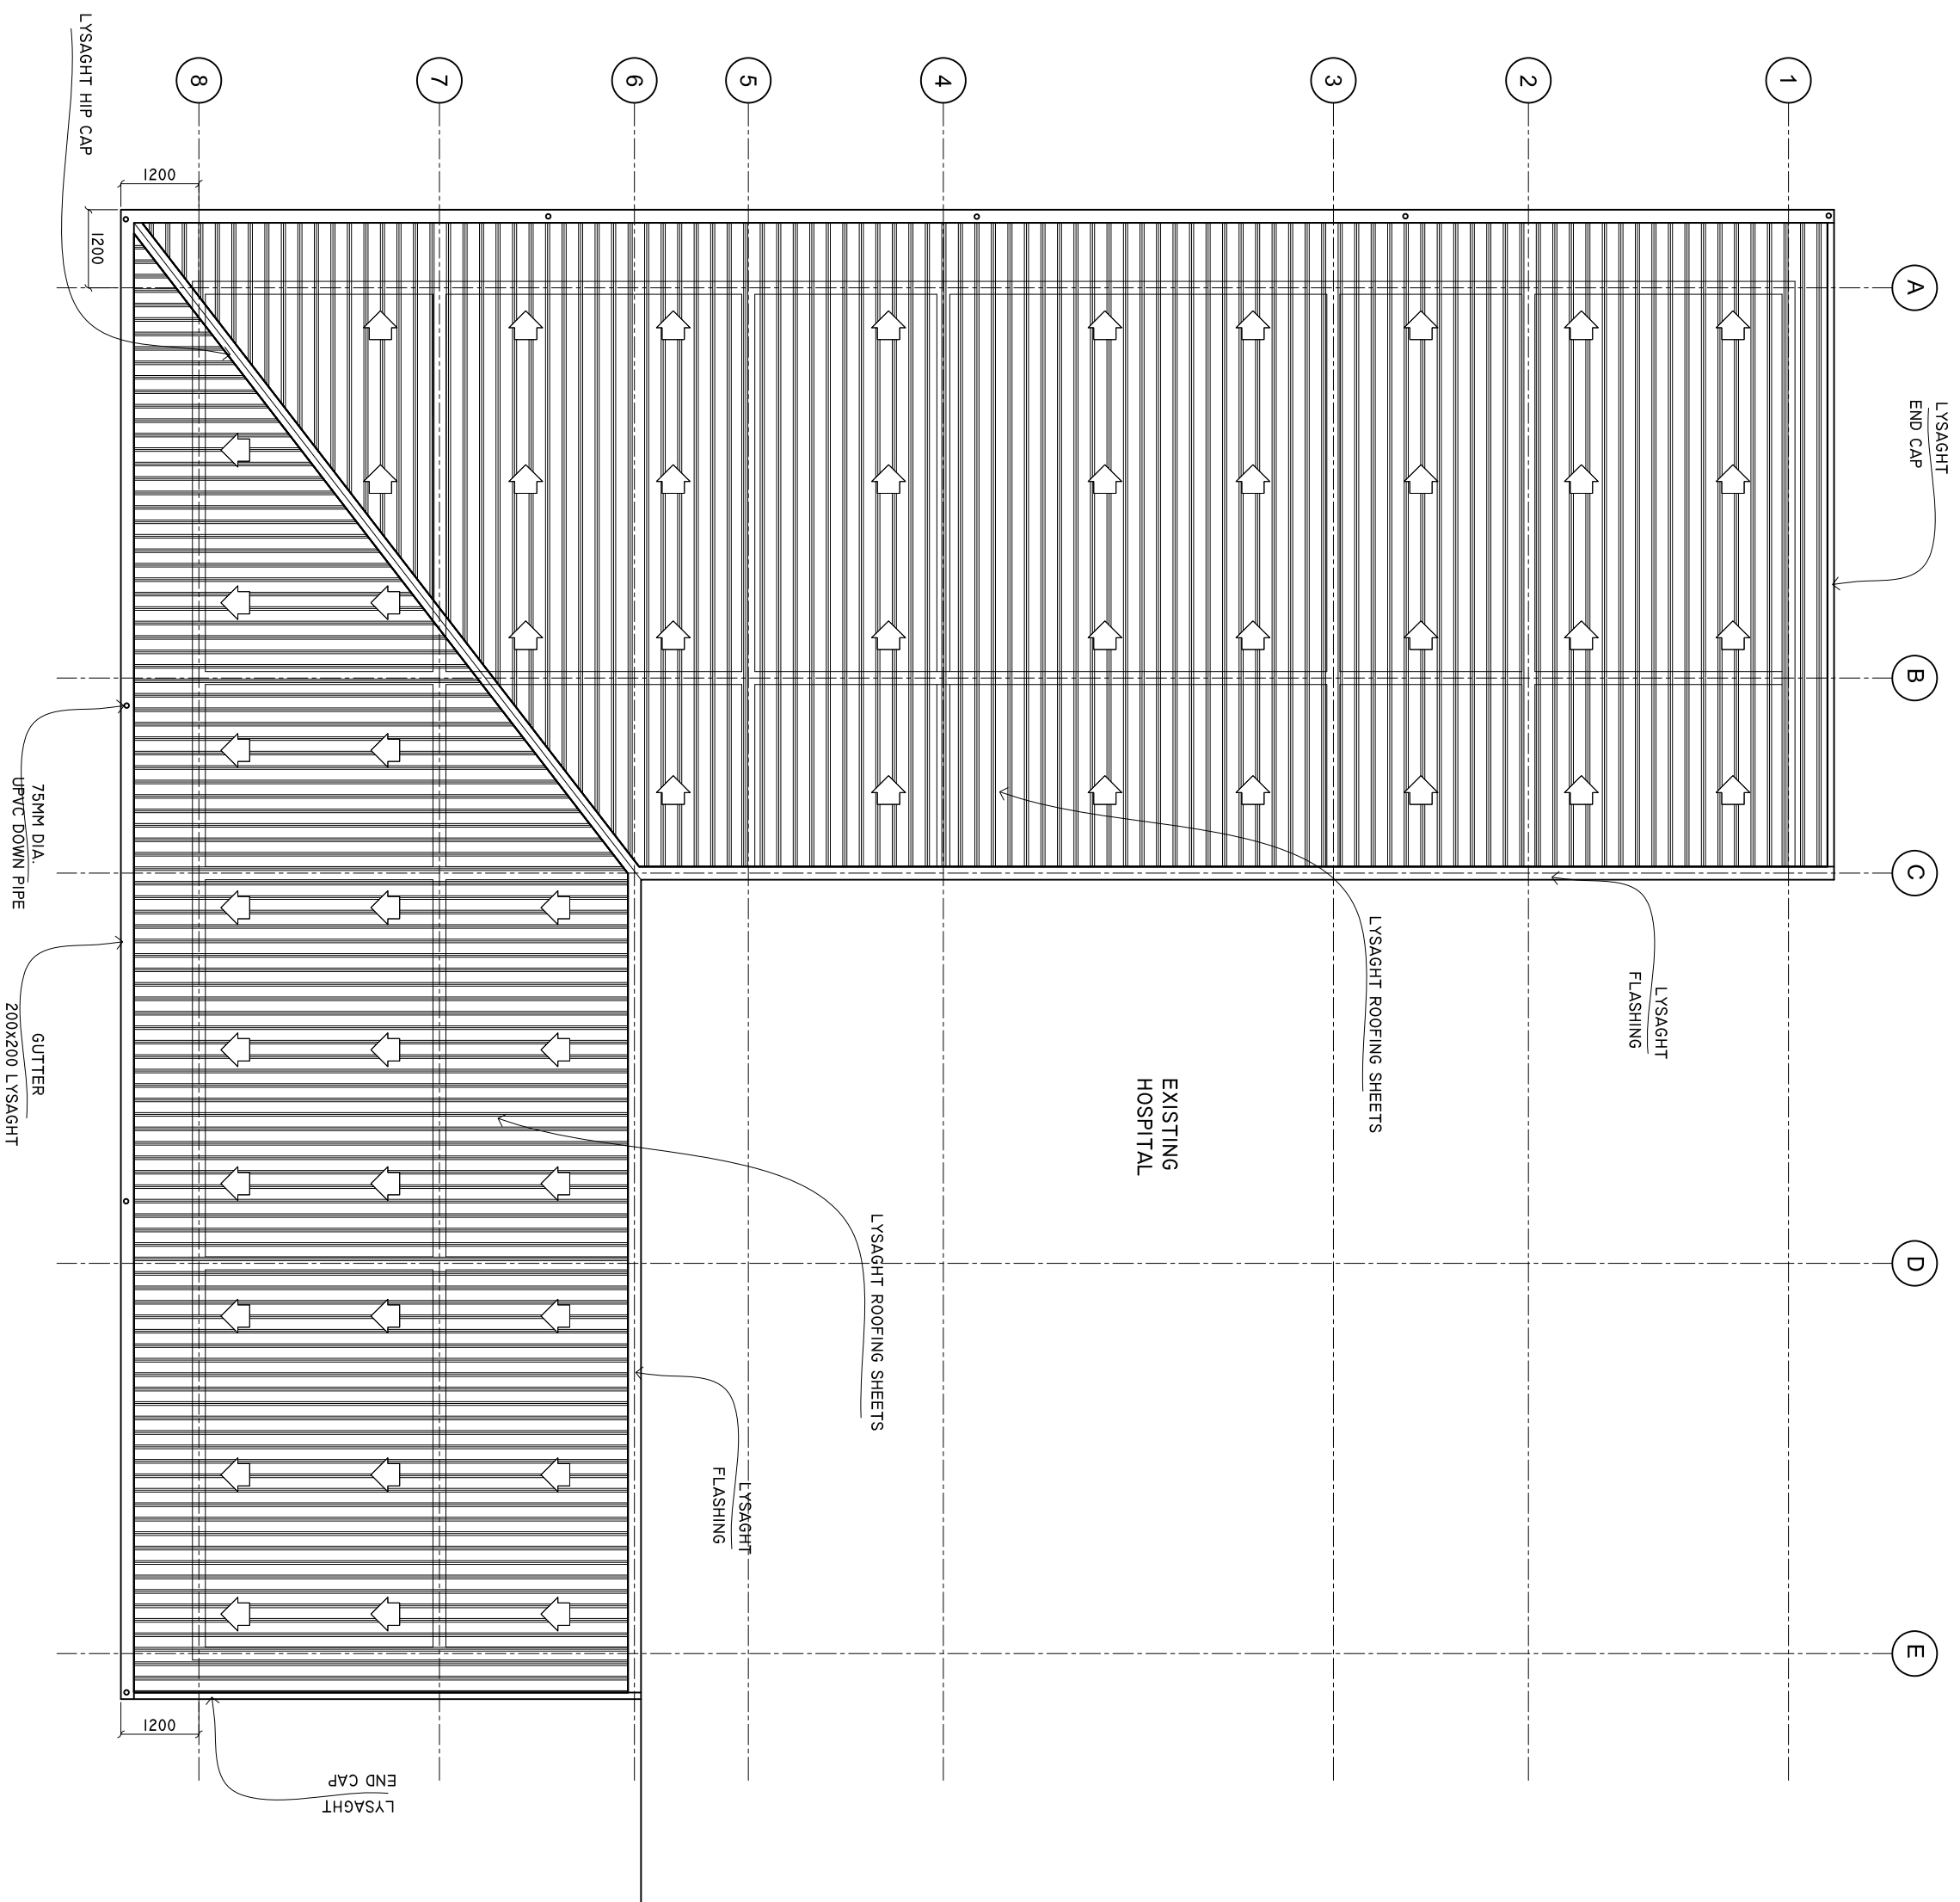

SHEET CONTENTS :

REVISION NOTES:

PROJECT:
CONSTRUCTION OF
EXTENSION WING

CLIENT:
MINISTRY OF HEALTH

LOCATION:
B. EYDHAFUSHI

CONTENTS: AS GIVEN

PROJECT MANAGER:

DESIGNER: ARIZ

CIVIL/STR. ENGINEER

SUPERVED BY: -

DRAWN BY: ARIZ

CHECKED BY:


DATE : JAN 2020

SHEET NO. : /

PAPER SIZE: A2

ROOF FRAMING PLAN

SCALE: 1 : 100

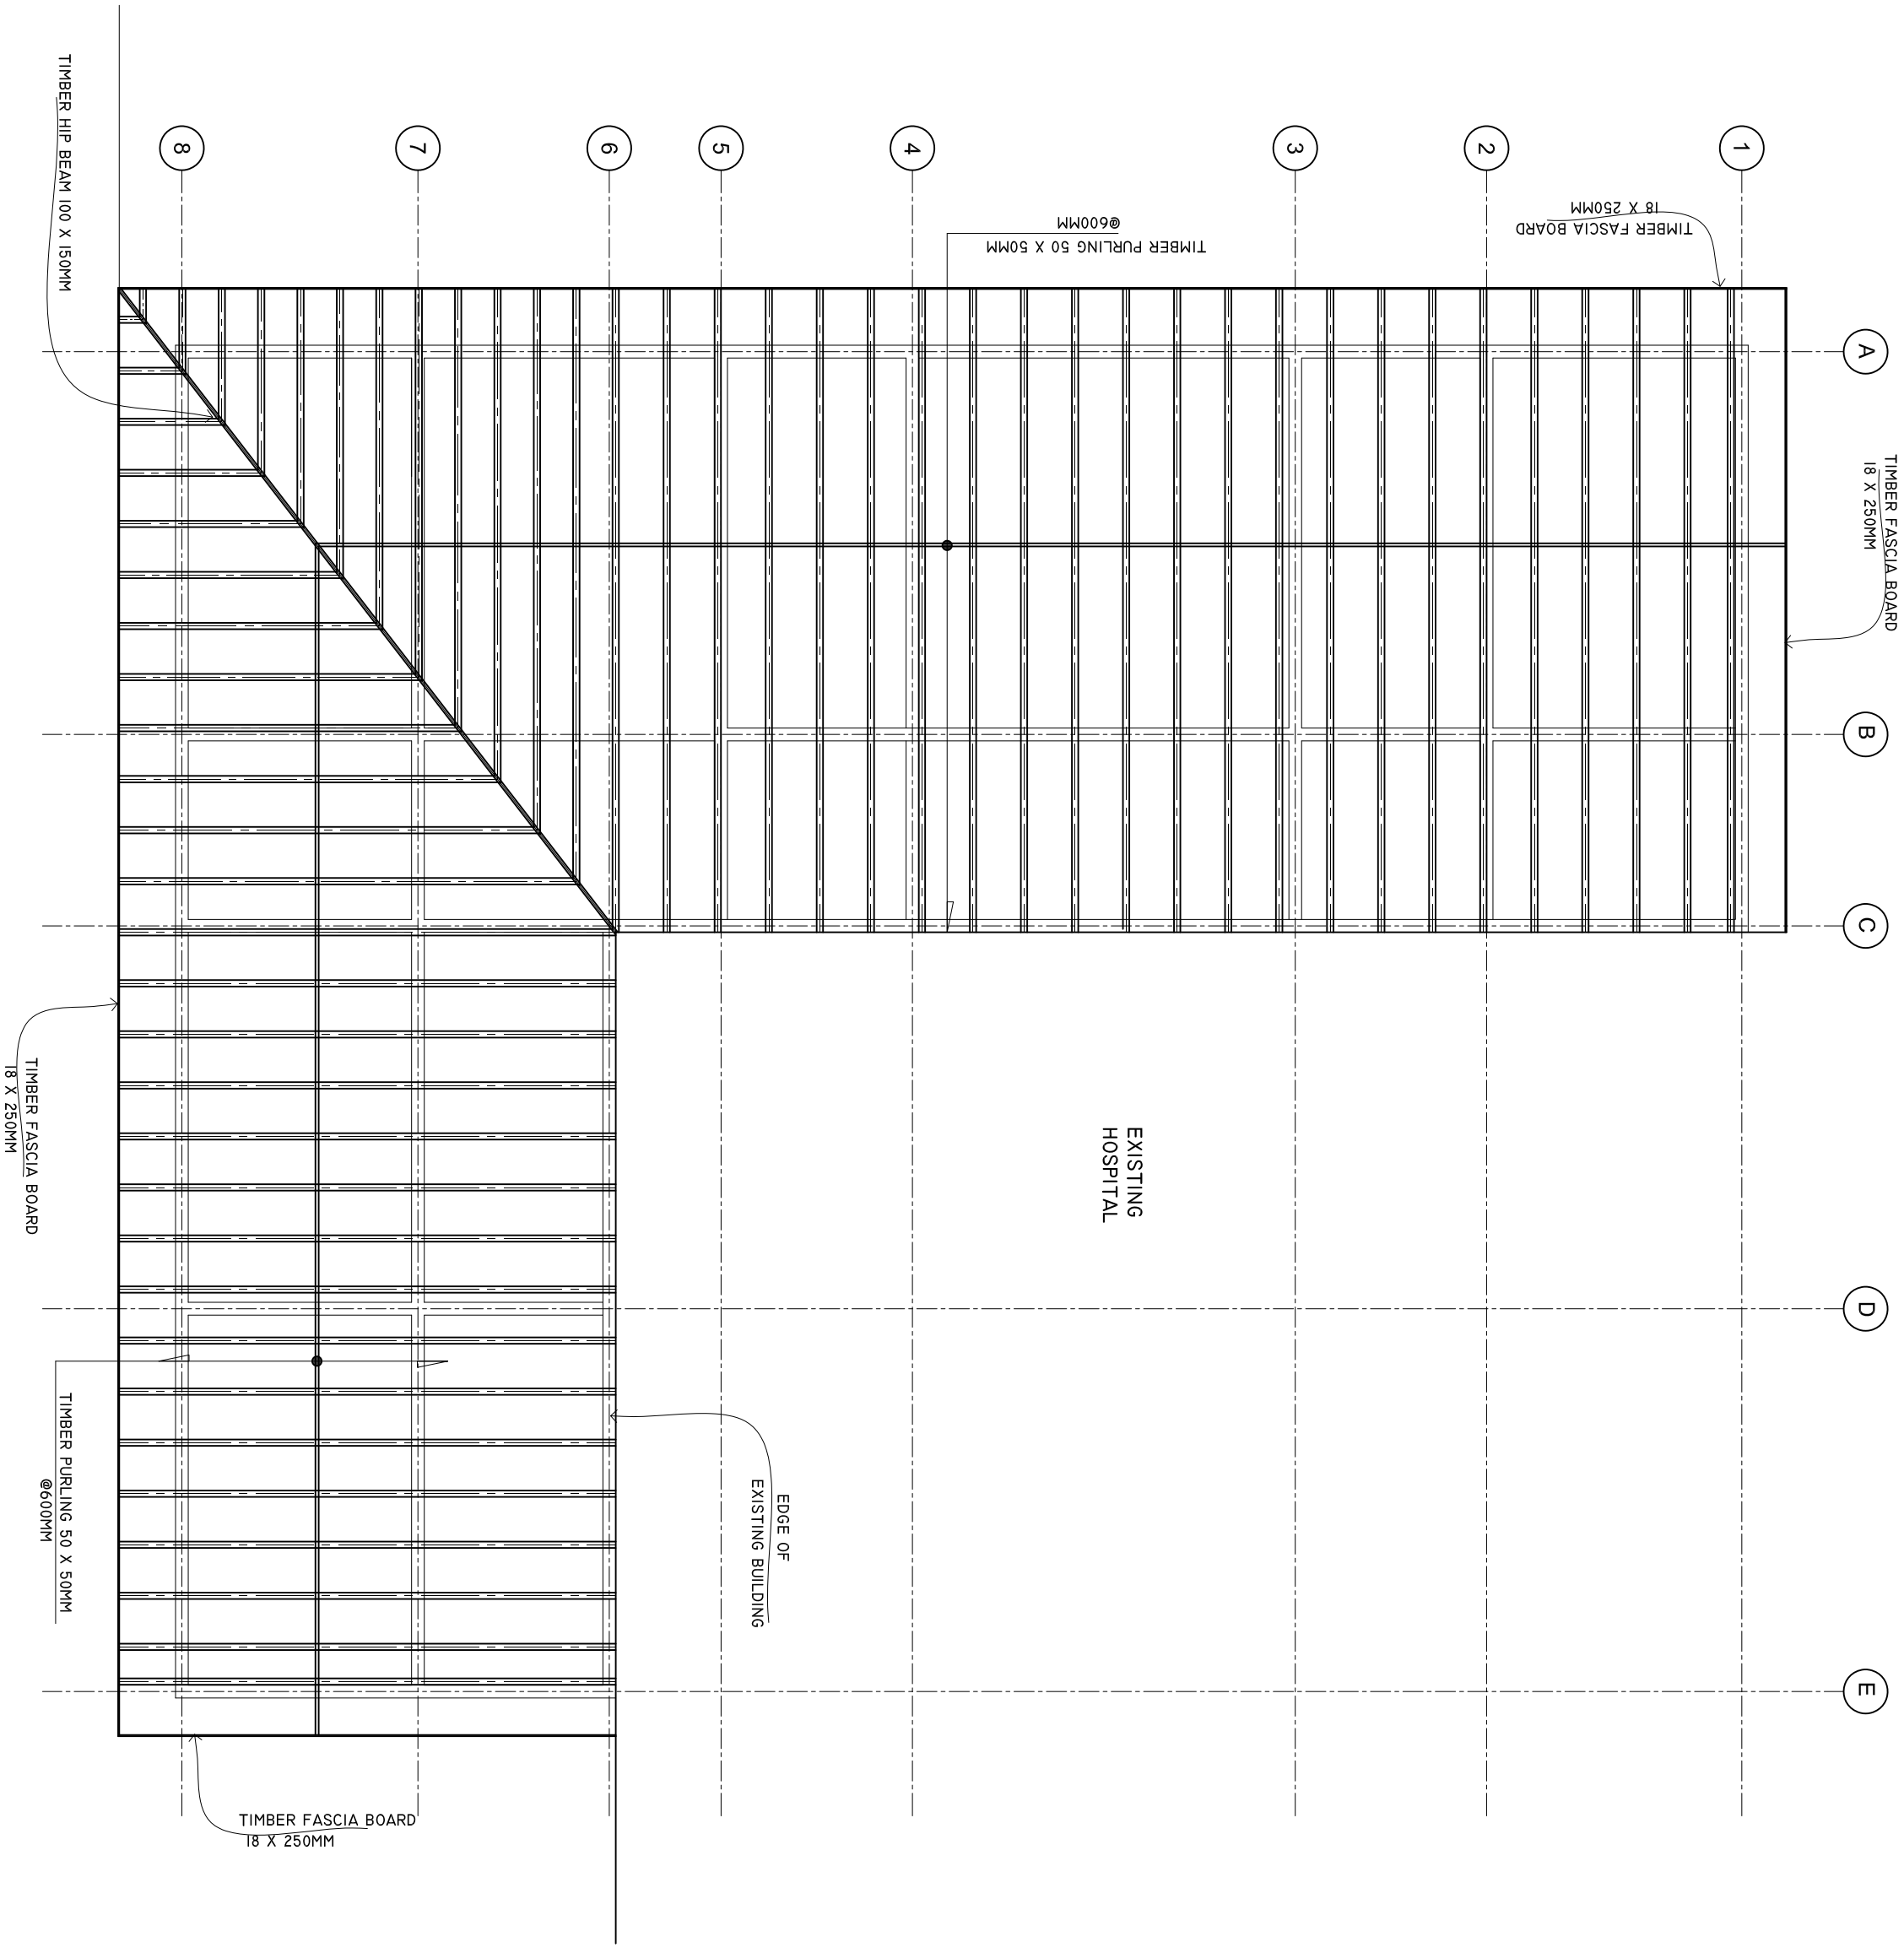

SHEET CONTENTS :

REVISION NOTES:

PROJECT:
CONSTRUCTION OF
EXTENSION WING

CLIENT:
MINISTRY OF HEALTH

LOCATION:
B. EYDAFUSHI

CONTENTS: AS GIVEN

PROJECT MANAGER:

DESIGNER: ARIZ

CIVIL/STR. ENGINEER

SUPERVED BY: -

DRAWN BY: ARIZ

CHECKED BY:


DATE : JAN 2020

SHEET NO. : /

PAPER SIZE: A2


ELEVATION B

SCALE: 1 : 100

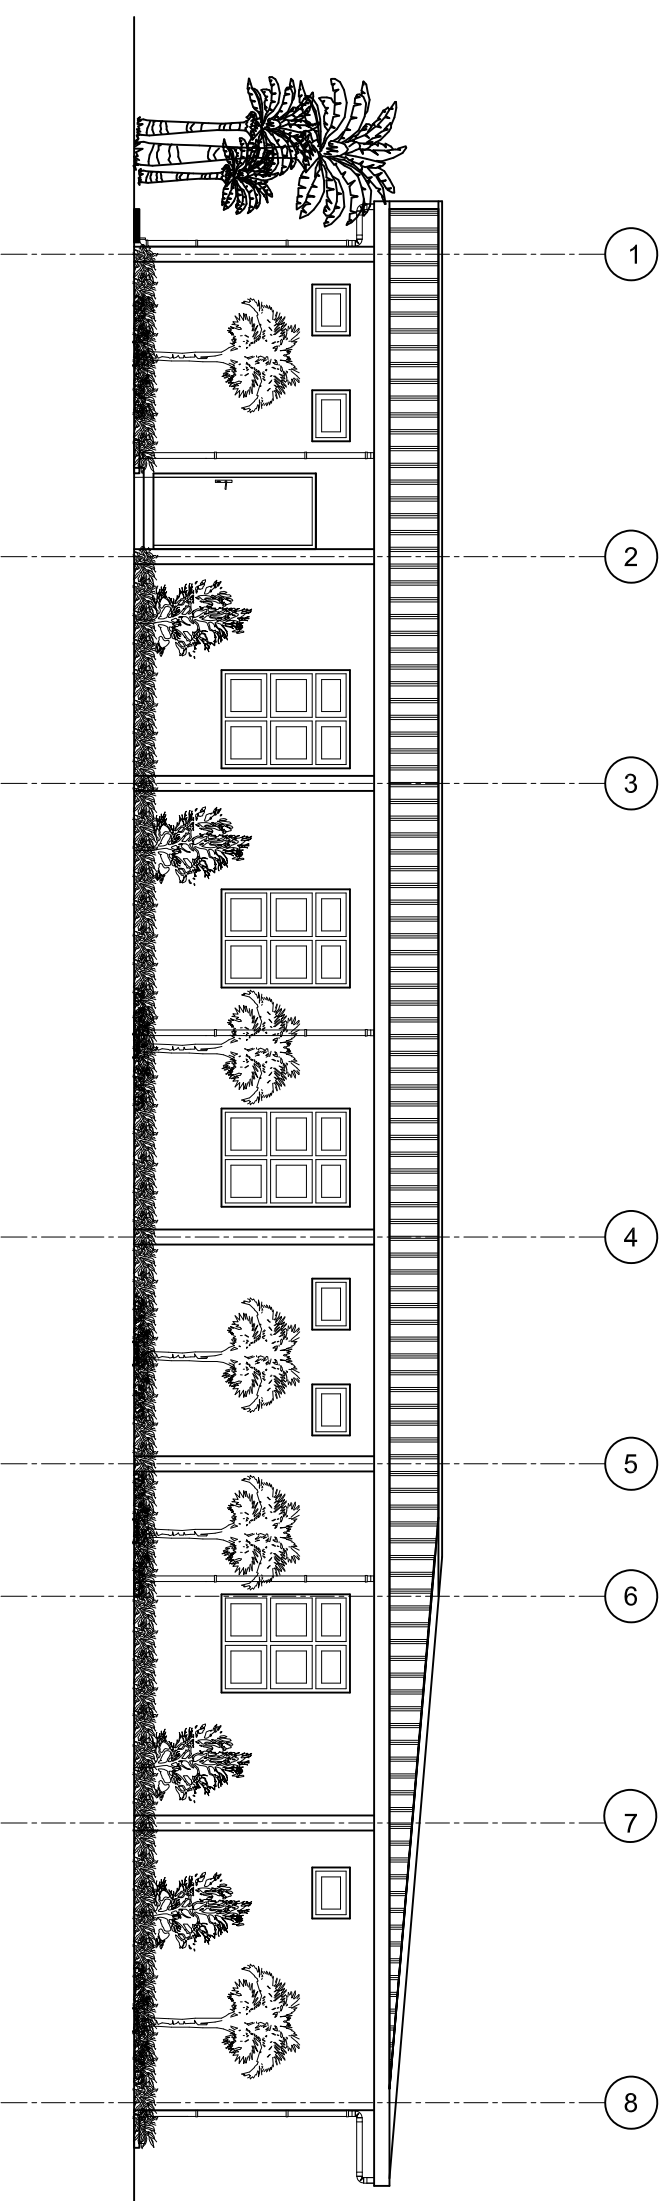

ELEVATION A

SCALE: 1 : 100

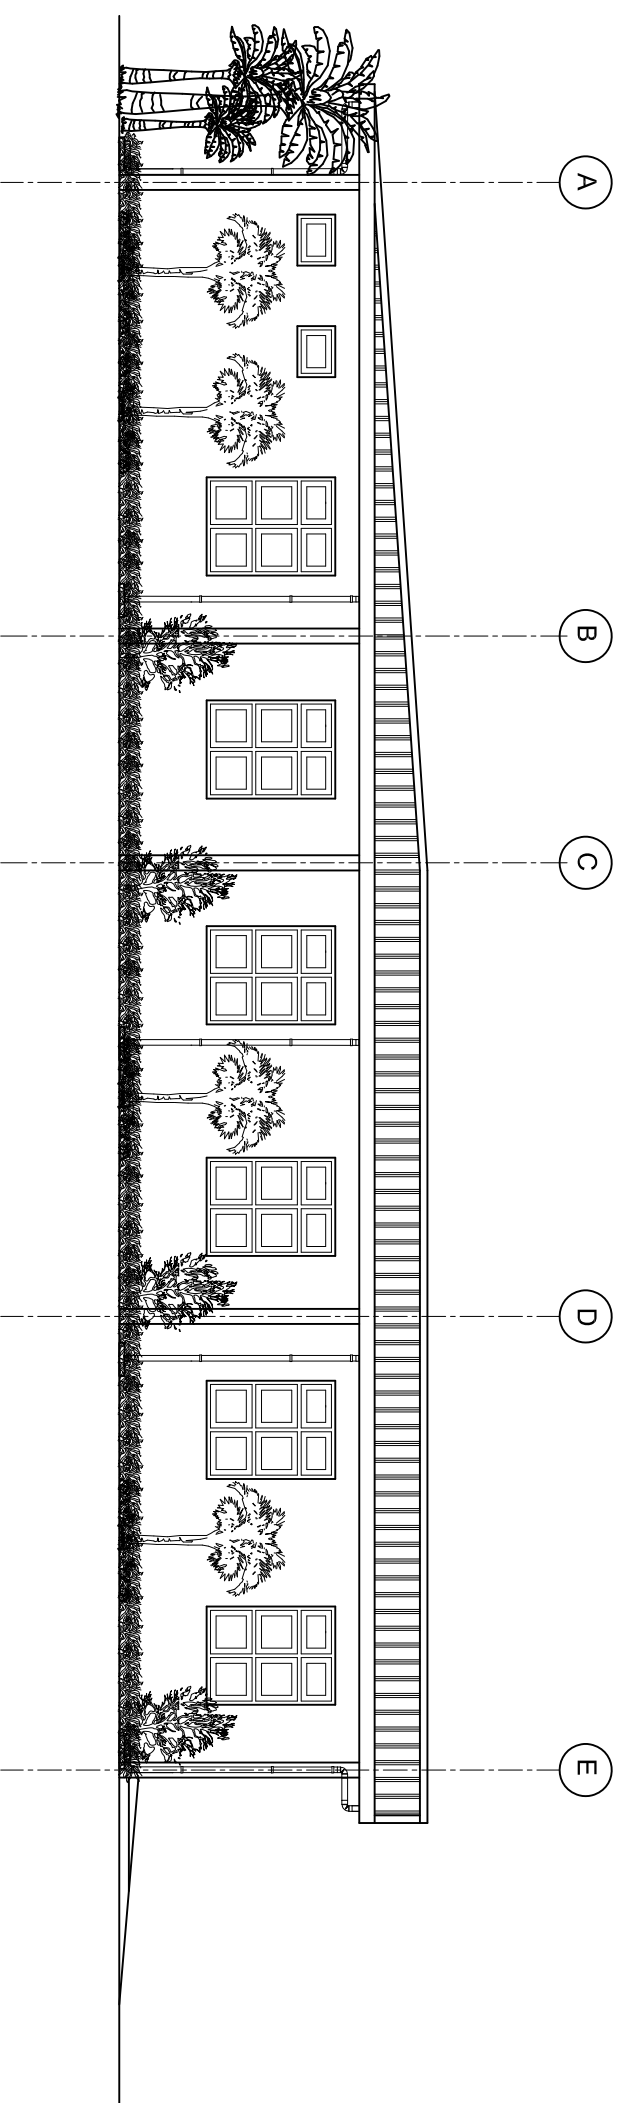

SHEET CONTENTS :

REVISION NOTES:

PROJECT:

CONSTRUCTION OF
EXTENSION WING

CLIENT:
MINISTRY OF HEALTH

LOCATION:
B. EYDHAUSHI

CONTENTS: AS GIVEN

PROJECT MANAGER:

DESIGNER: ARIZ

CIVIL/STR. ENGINEER:

SUPERVED BY: -

DRAWN BY: ARIZ

CHECKED BY:


DATE : JAN 2020 /

SHEET NO. : /

PAPER SIZE: A2

WALL DETAILS

SCALE: 1 : 100

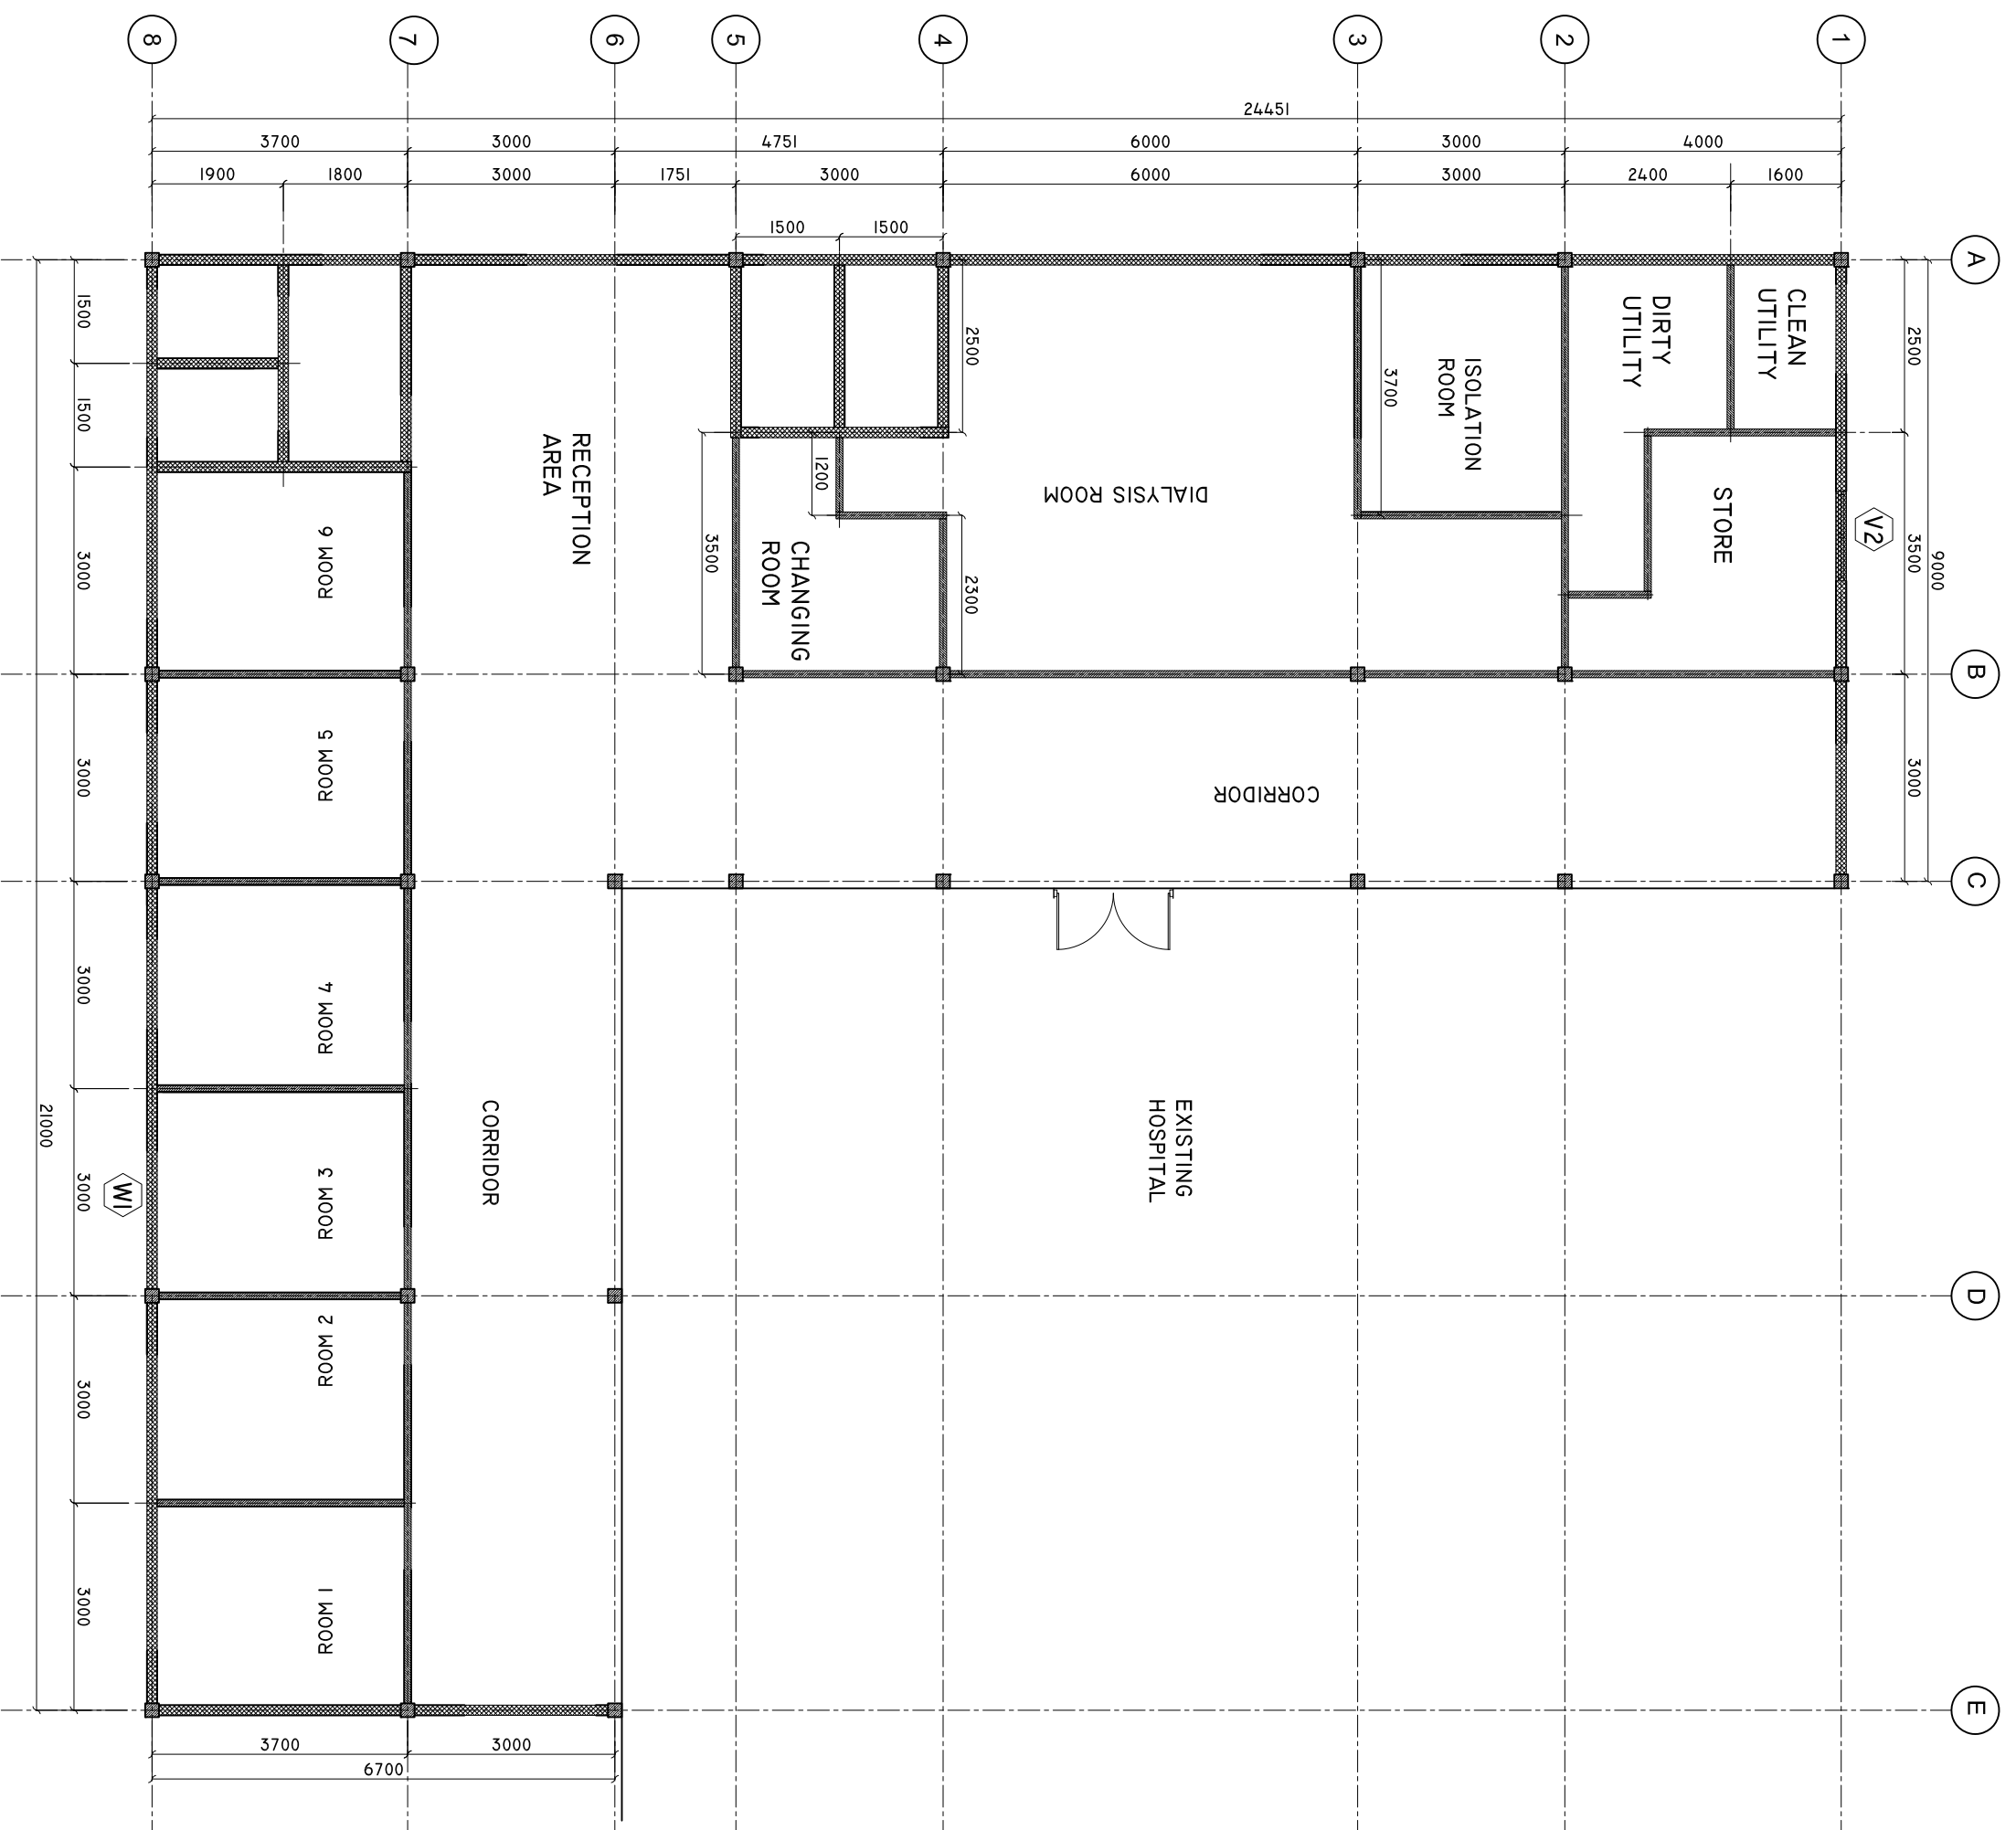

150MM THICK HOLLOW BLOCK MASONRY WALL
 100MM THICK DRYWALL PARTITION

SHEET CONTENTS :

REVISION NOTES:

PROJECT:

CONSTRUCTION OF EXTENSION WING

CLIENT: MINISTRY OF HEALTH

LOCATION: B. EYDAHUSHI

CONTENTS: AS GIVEN

PROJECT MANAGER:

DESIGNER: ARIZ

CIVIL/STR. ENGINEER:

SUPERVED BY: -

DRAWN BY: ARIZ

CHECKED BY: -


DATE : JAN 2020 /

SHEET NO. : /

PAPER SIZE: A2

ELECTRICAL LAYOUT

SCALE: 1 : 100

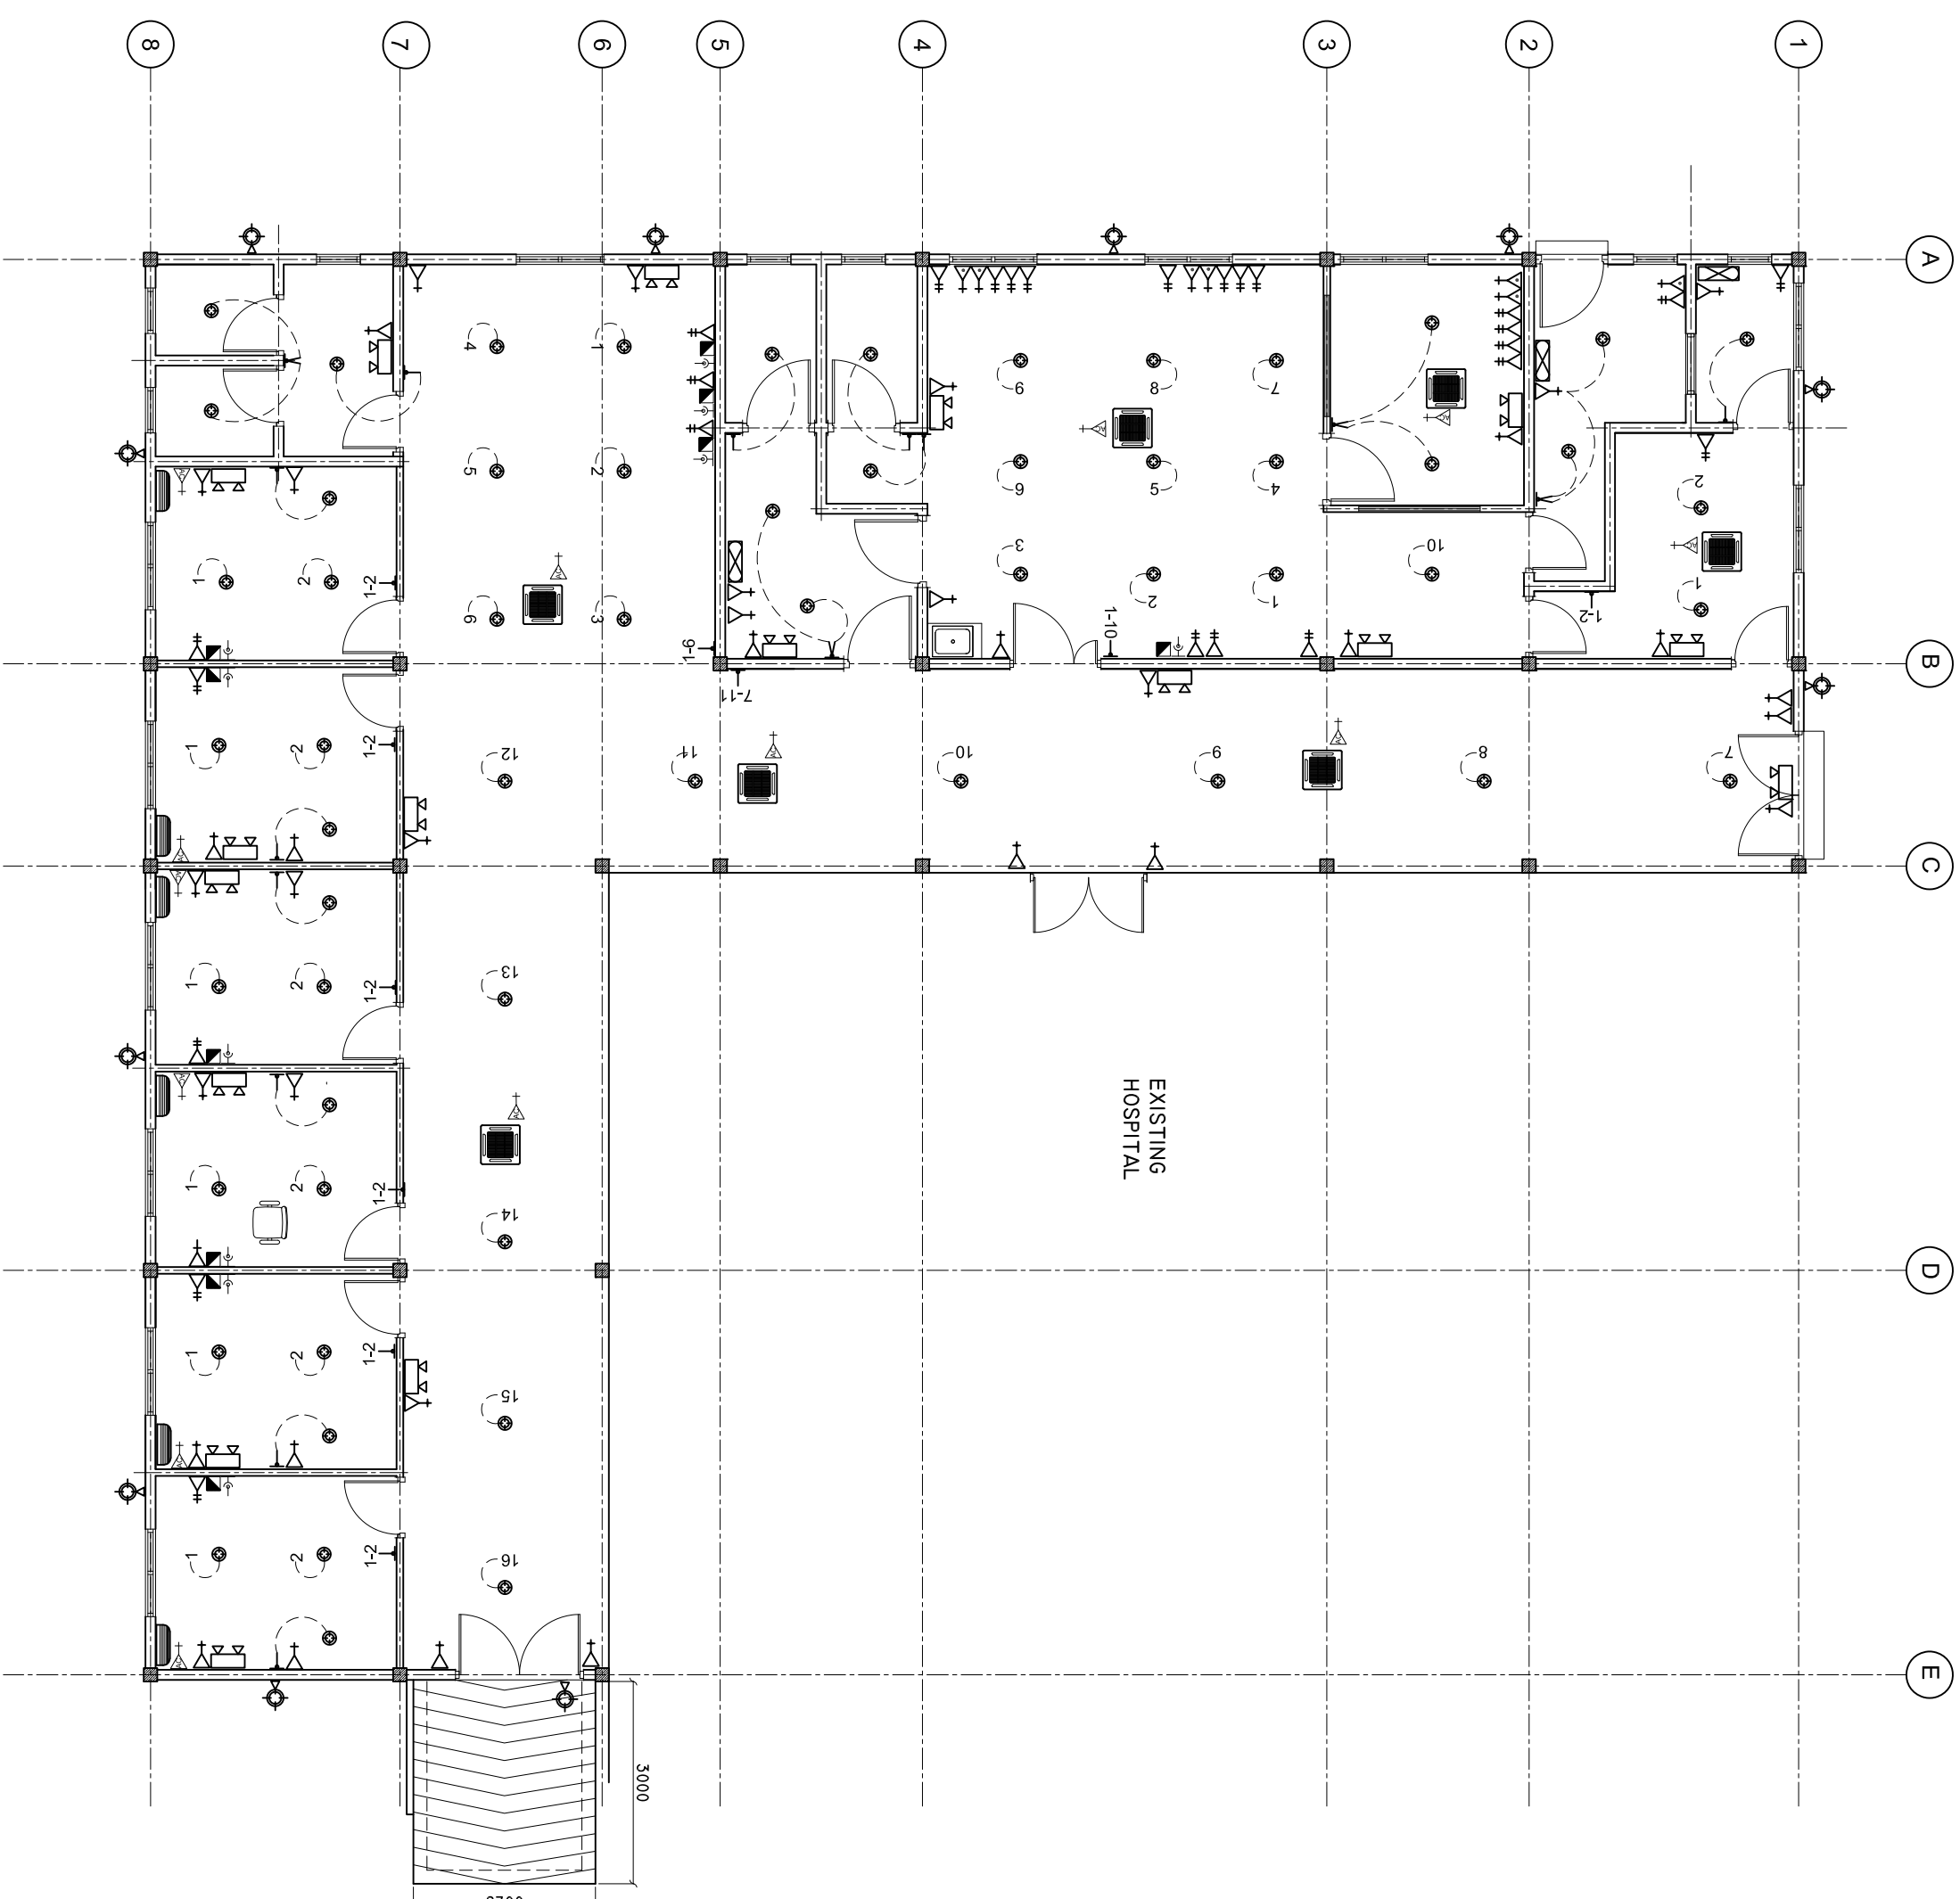

LEGEND

SYMBOL	DESCRIPTION
	LED BULB WITH 150MM DOWN LIGHT
	1 x 13 AMP SOCKET OUTLET (1600MM ABOVE FFL)
	2 x 13 AMP SOCKET OUTLET (600MM ABOVE FFL)
	1 x 15 AMP SOCKET OUTLET (600MM ABOVE FFL)
	1 x 15 AMP AC SOCKET OUTLET (300MM BL.W. CEILING)
	TWO GANG SWITCH
	ONE WAY SWITCH
	EMERGENCY LIGHT
	DISTRIBUTION BOARD (WALL EMBEDDED)
	AC WALL MOUNT UNIT
	TELEPHONE SOCKET
	NETWORK SOCKET

LEGEND

SYMBOL	DESCRIPTION
	1 x 13 AMP SOCKET OUTLET (200MM BELOW CEILING)
	WALL MOUNT FAN
	FAN REGULATOR
	SW BULB WITH COVERED
	CEILING FAN 1200MM DIA.
	AC INDOOR UNIT, CEILING CASSETTE TYPE
	OUTDOOR LIGHT

SHEET CONTENTS :

PROJECT: CONSTRUCTION OF EXTENSION WING

CLIENT: MINISTRY OF HEALTH

LOCATION: B. EYDAHUSHI

CONTENTS: AS GIVEN

PROJECT MANAGER: DESIGNER: ARIZ

CIVIL/STR. ENGINEER: SUPERVED BY: -

DRAWN BY: ARIZ


CHECKED BY: DATE : JAN 2020

SHEET NO. : /

PAPER SIZE: A2

COLUMN LAYOUT

SCALE: 1 : 100

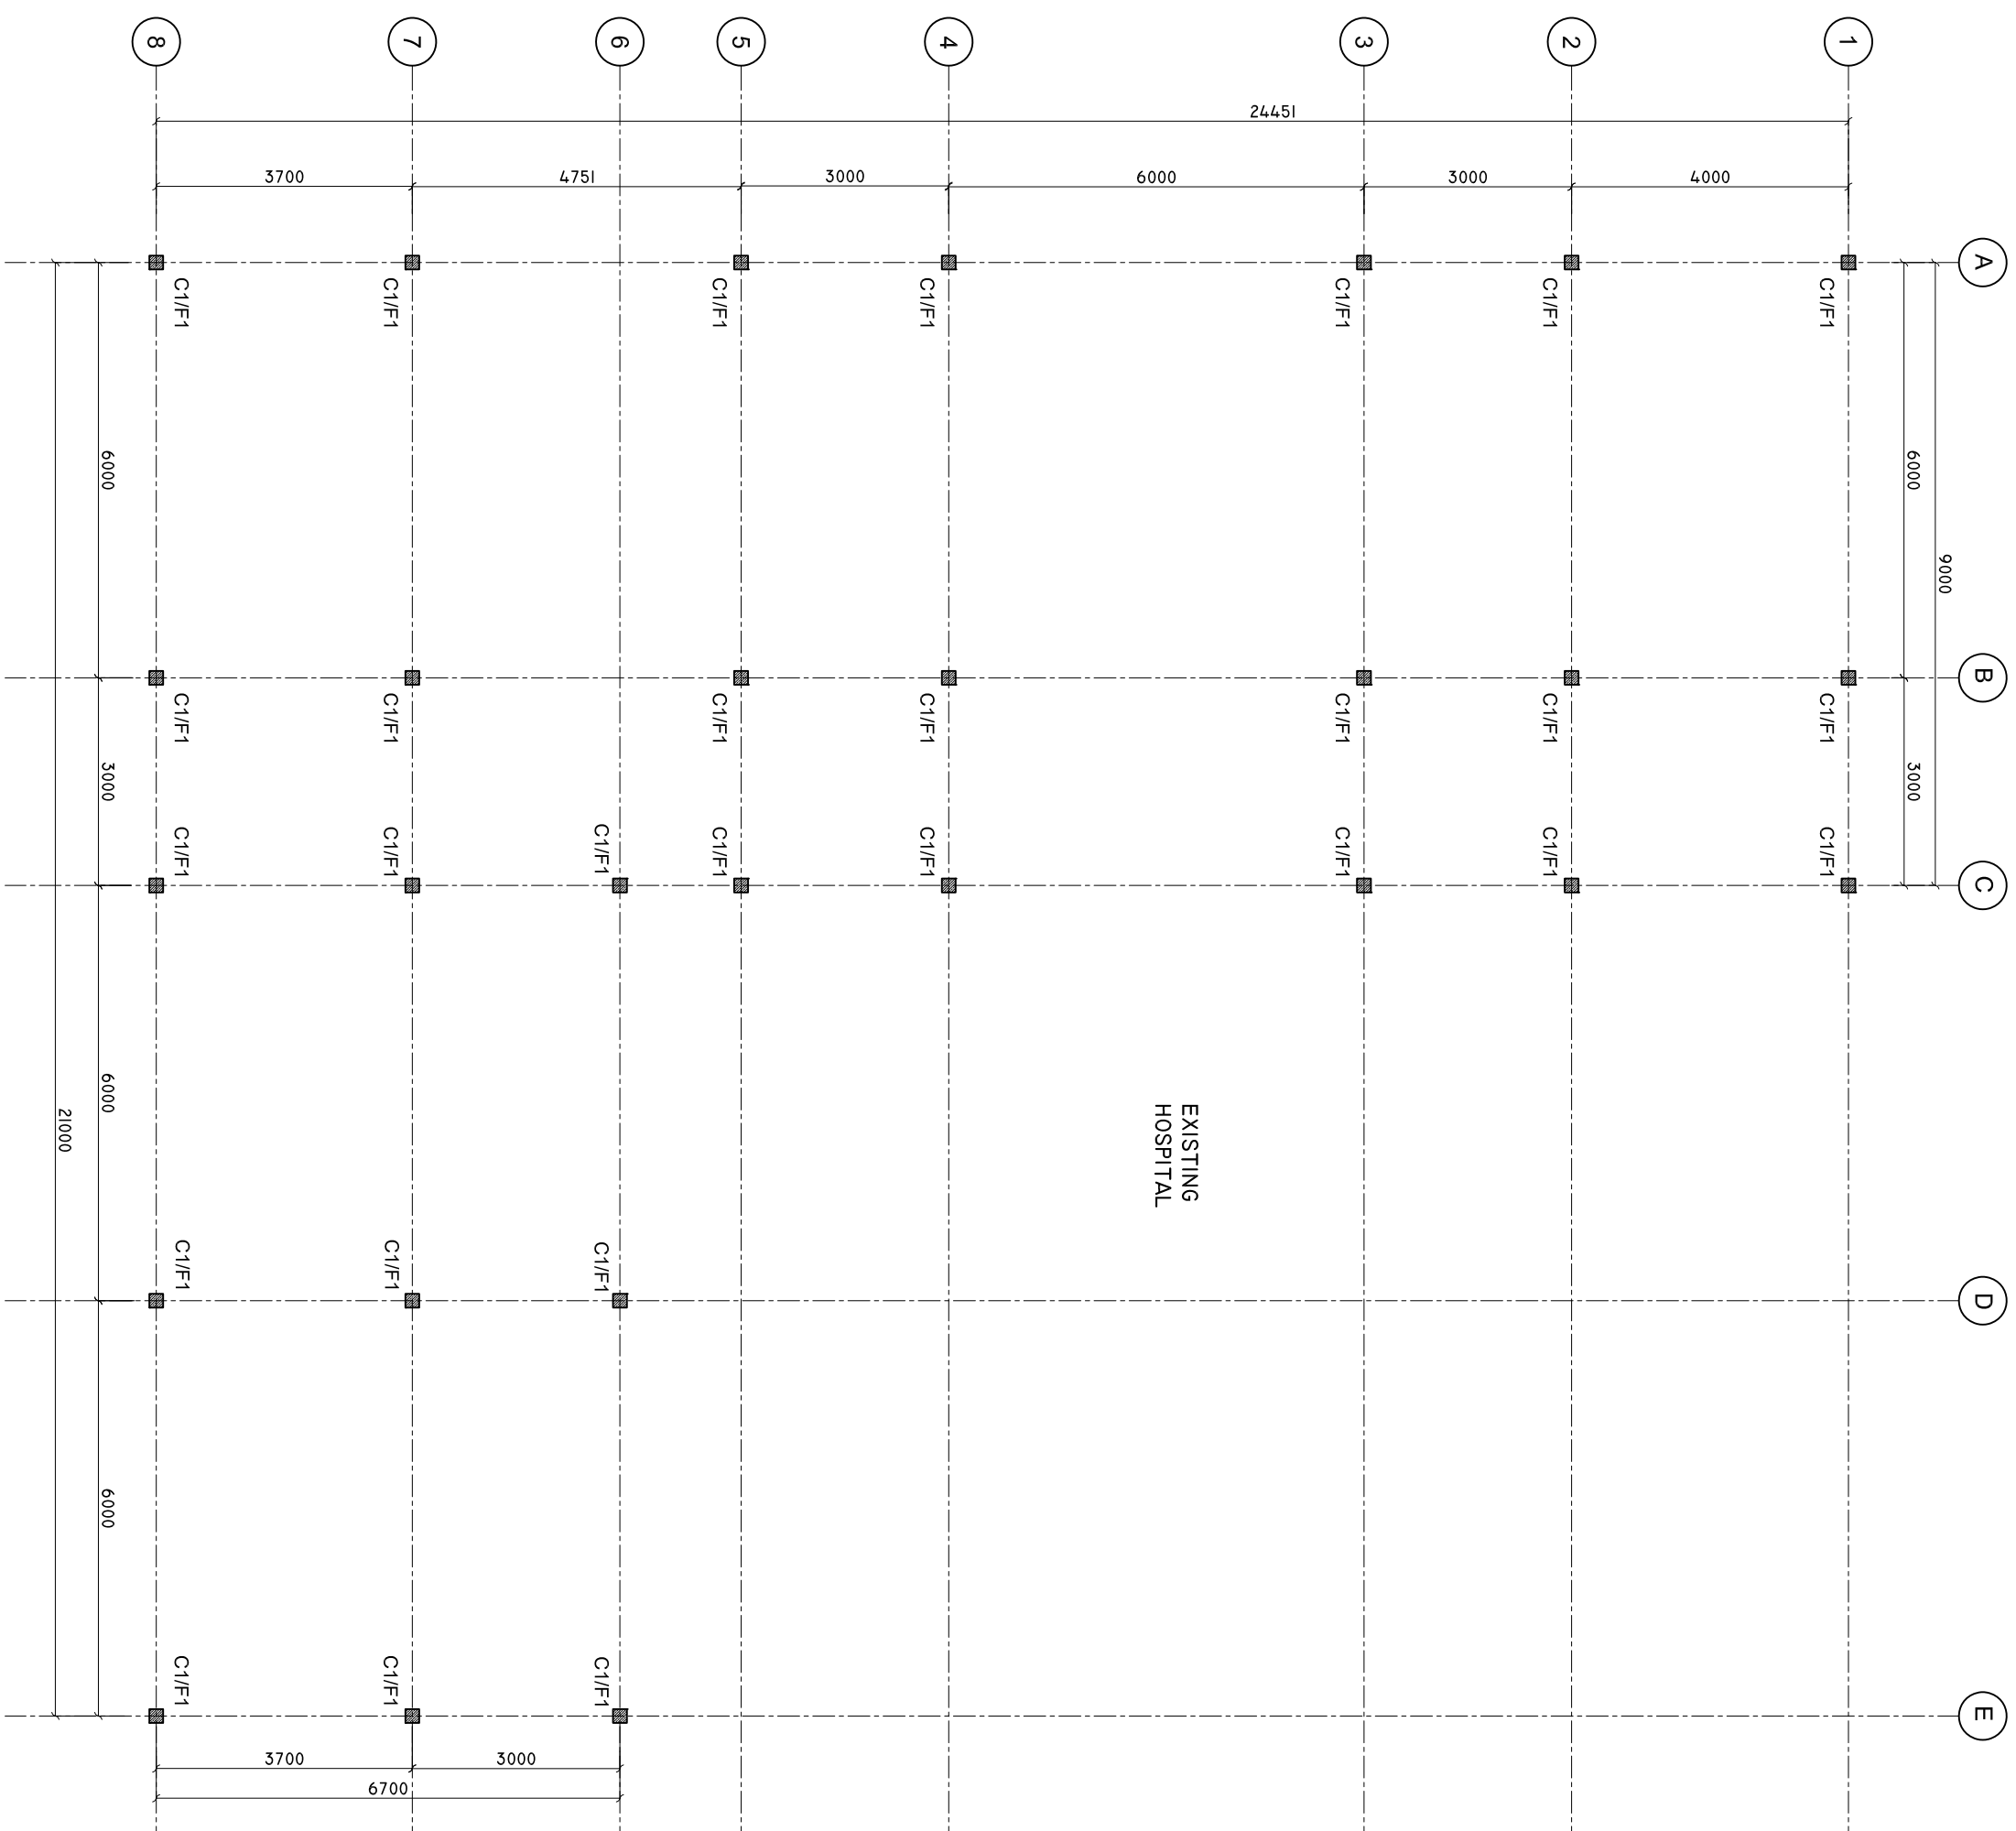

SHEET CONTENTS :

REVISION NOTES:

PROJECT:
CONSTRUCTION OF
EXTENSION WING

CLIENT:
MINISTRY OF HEALTH

LOCATION:
B. EYDAHUSHI

CONTENTS: AS GIVEN

PROJECT MANAGER:

DESIGNER: ARIZ

CIV/STR. ENGINEER:

SUPERVED BY: -


DRAWN BY: ARIZ

CHECKED BY: -

DATE: JAN 2020 /

SHEET NO. : /


PAPER SIZE: A2

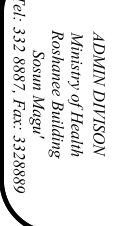

ADNAN OJIRSON
Ministry of Health
Roshana Building
Sana'a, Yemen
Tel: 332 8887 Fax: 3328899

TIE BEAM PLAN

SCALE: 1 : 100

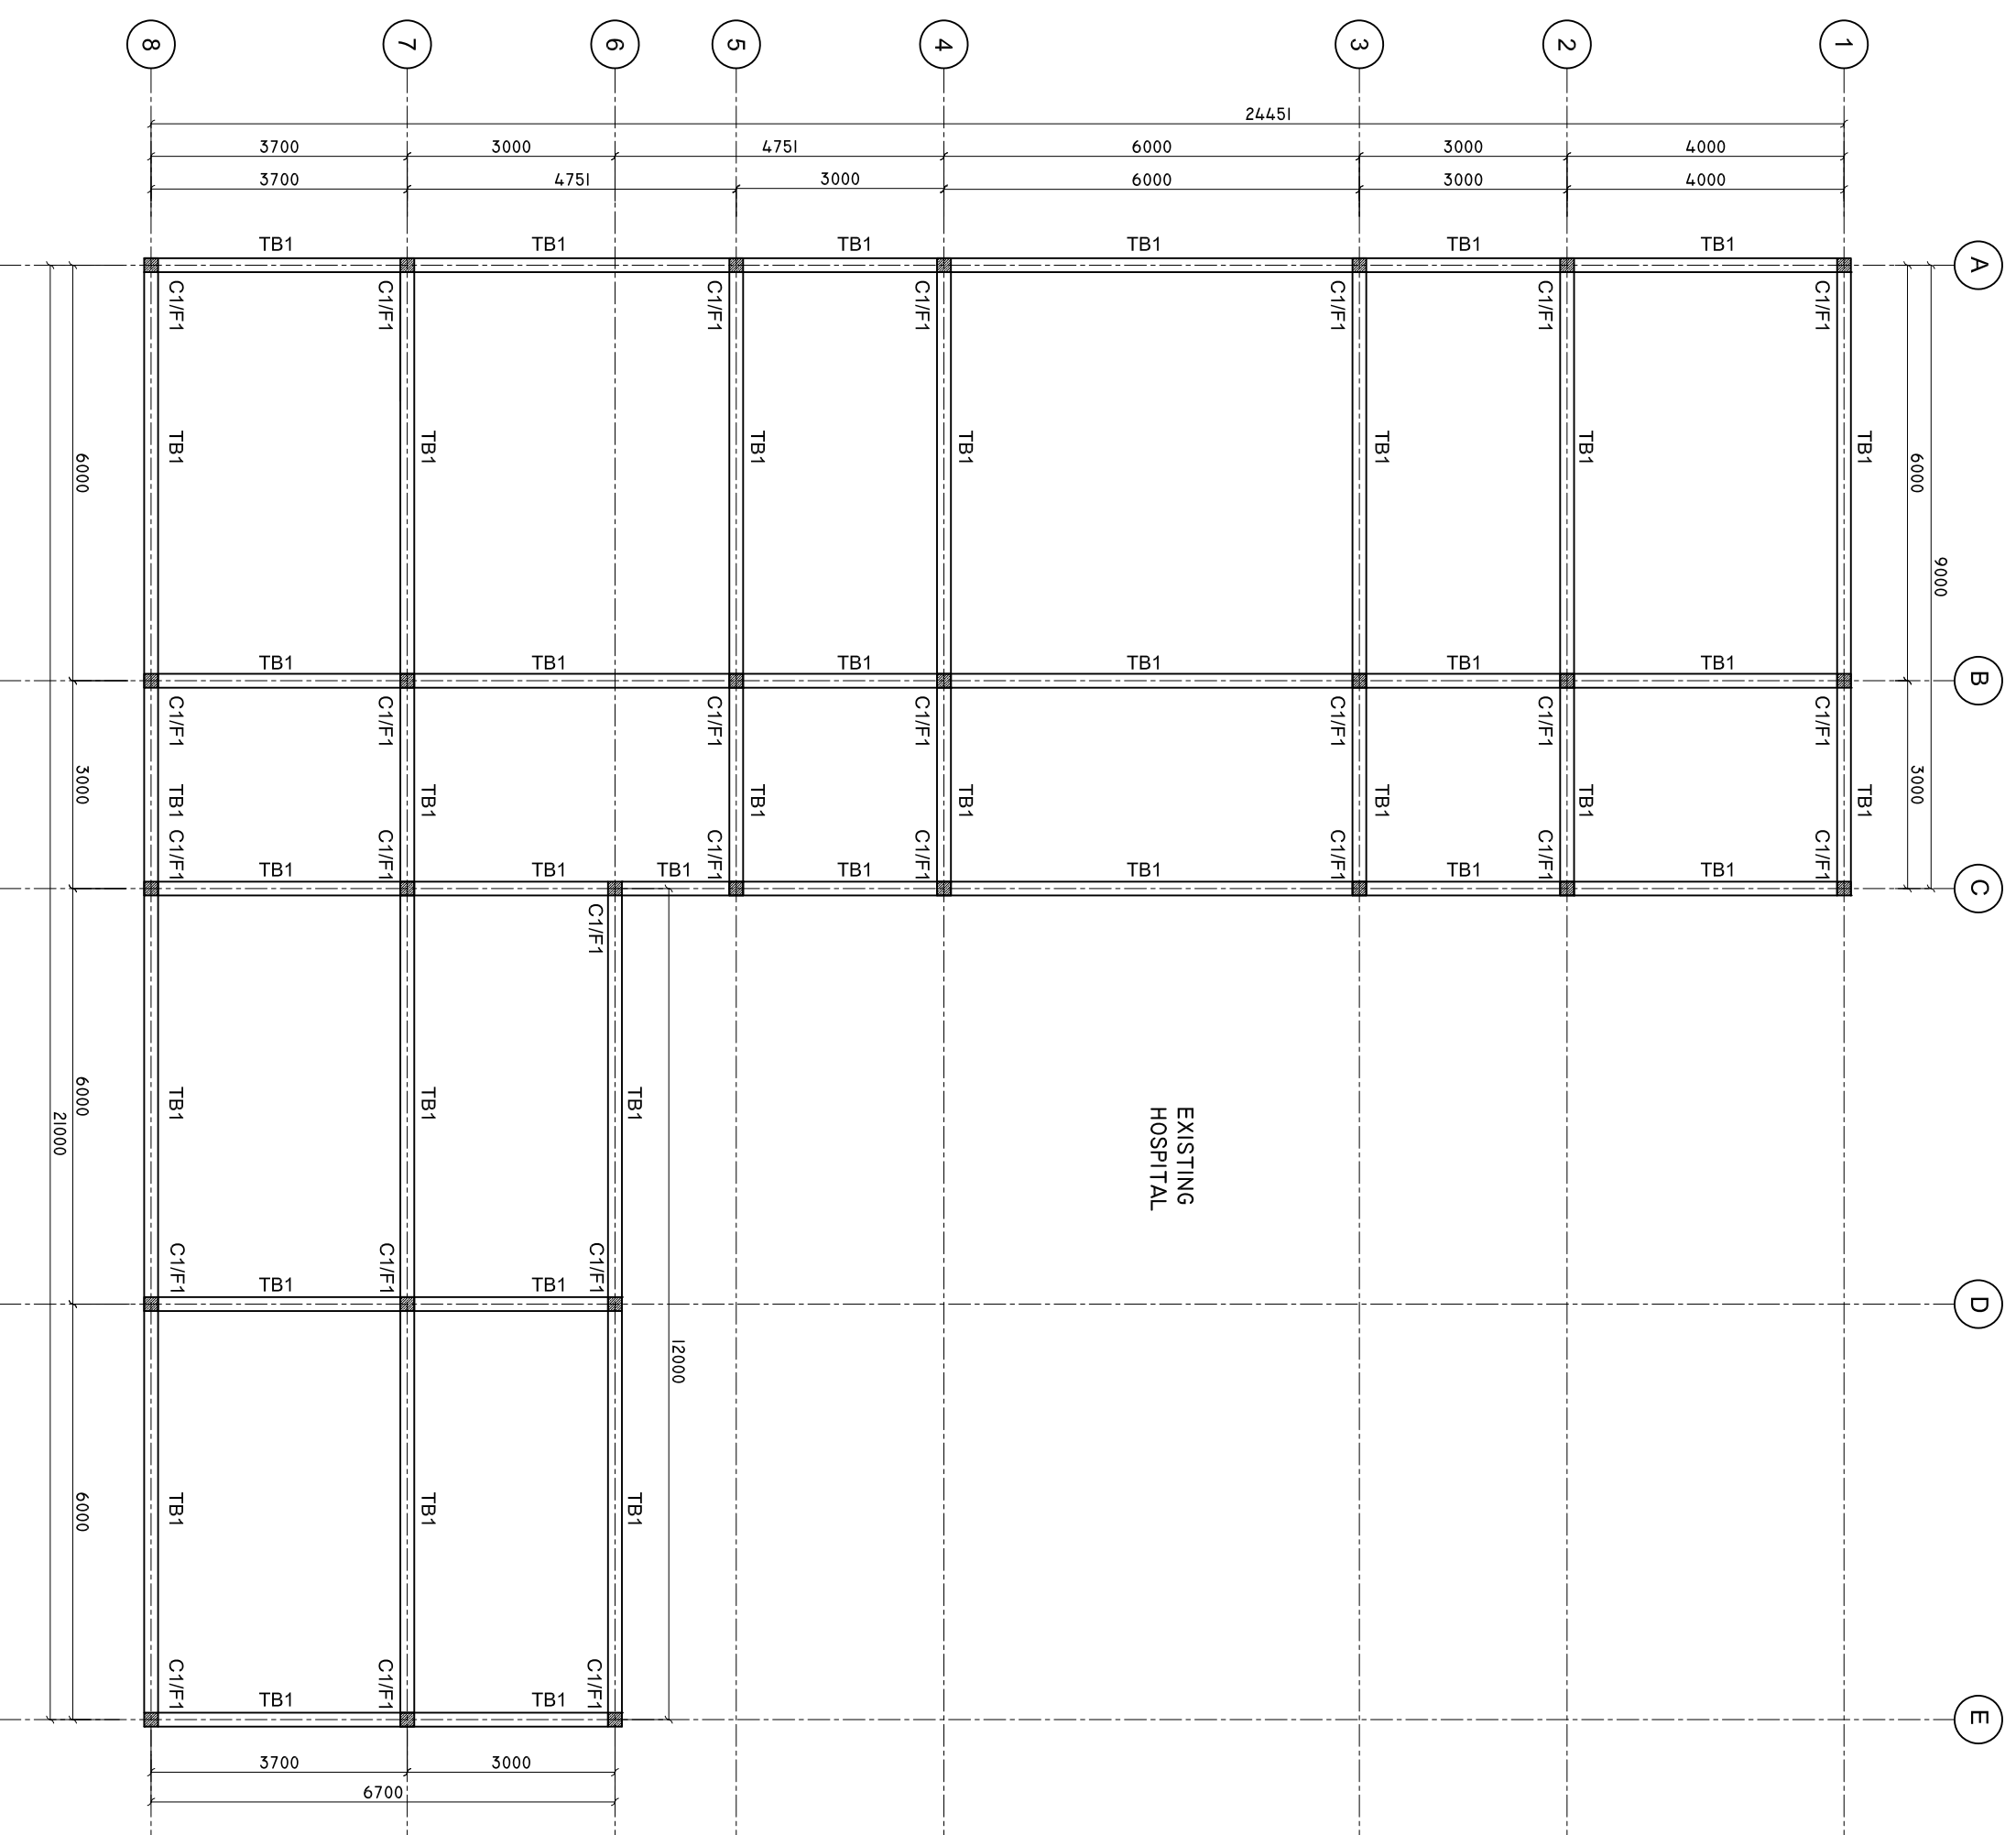

SHEET CONTENTS :

PROJECT:
CONSTRUCTION OF
EXTENSION WING

CLIENT:
MINISTRY OF HEALTH

LOCATION:
B. EYDAHUSHI

CONTENTS: AS GIVEN

PROJECT MANAGER:

DESIGNER: ARIZ

CIVIL/STR. ENGINEER:

SUPERVED BY: -

DRAWN BY: ARIZ

CHECKED BY: -

DATE: JAN 2020

SHEET NO. : /

PAPER SIZE: A2