

FOOTBALL STADIUM CHANGING ROOM, SEATINGS, CAFE', SHOP
ARCHITECTURAL, STRUCTURAL, ELECTRICAL & PLUMBING DRAWINGS
01-22-2020


SIARCH
P R I V A T E L I M I T E D
LONUZIYAARAIY MAGU, MALE', 20075, MALDIVES
EMAIL: I N F O @ S I A R C H . D E S I G N
H T T P / / : W W W . S I A R C H . D E S I G N

WARNING:


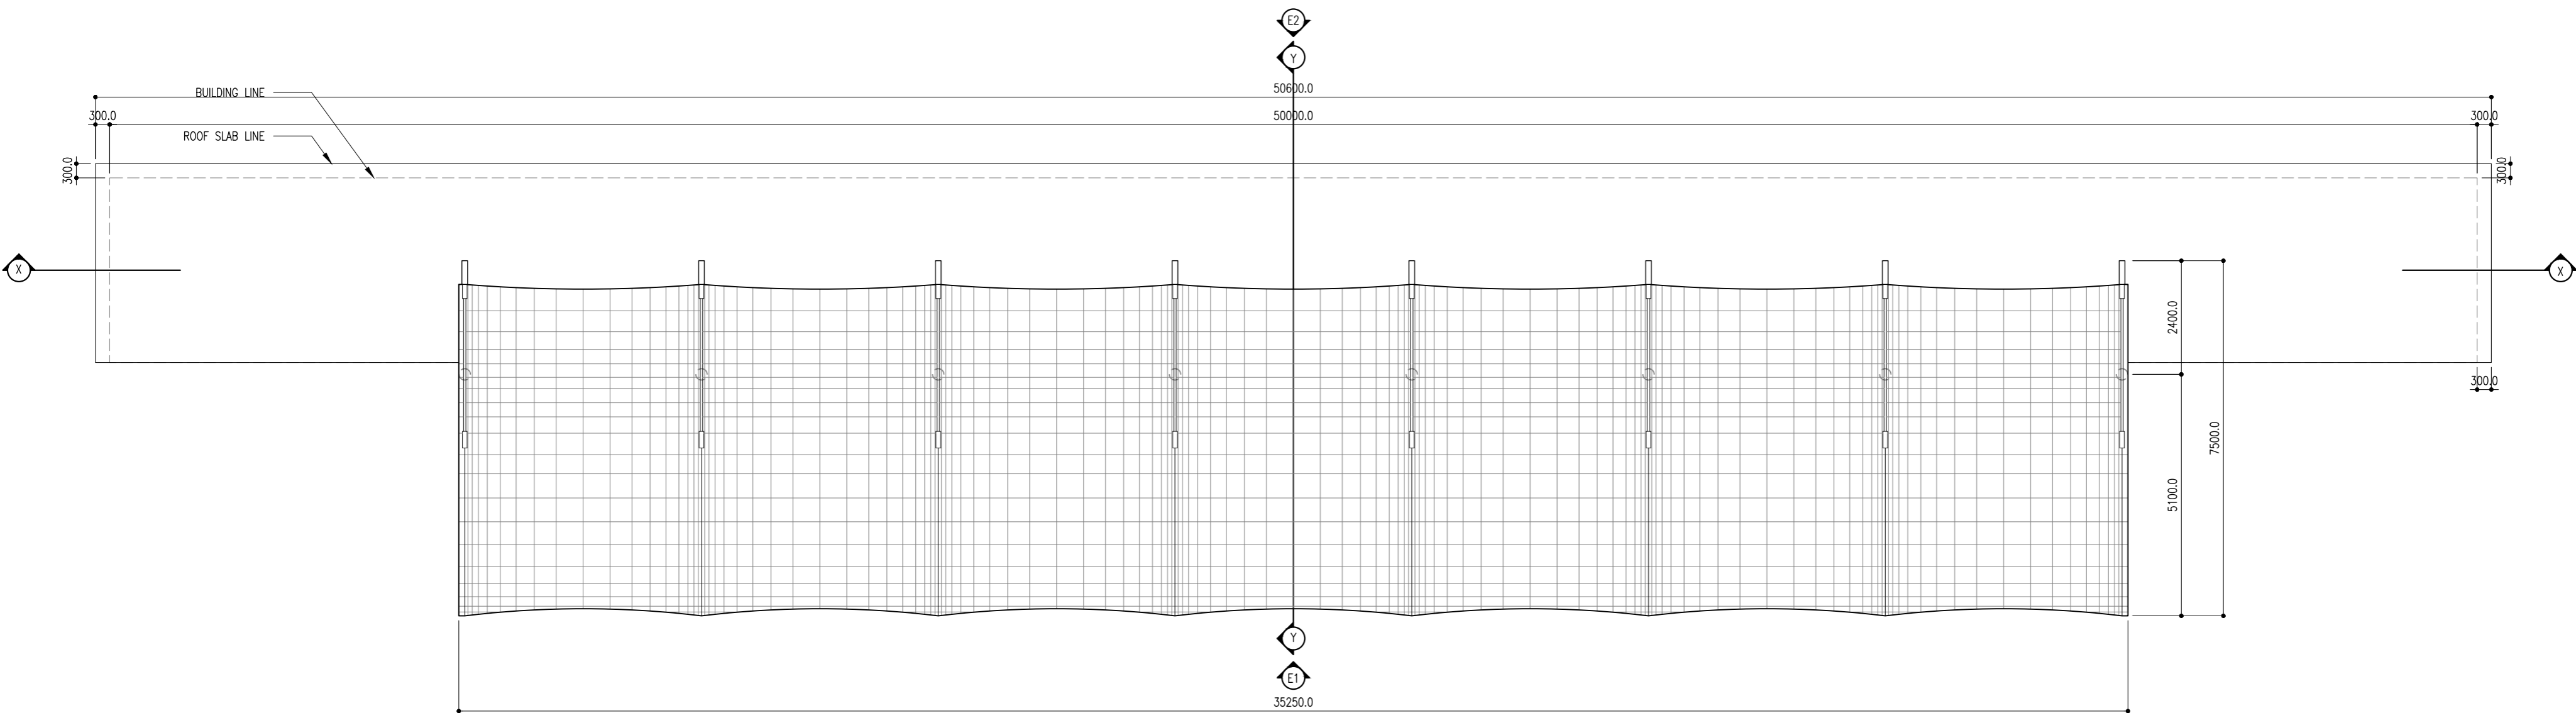
This drawing shall not be used for construction unless certified.
Contractor to verify all dimensions of existing works on site before commencing any work or preparing shop drawings. Do not scale drawings, use written dimensions only.
This drawing is to be read in conjunction with the specifications and conditions of contract.
This drawing and design is copyright and no portion may be reproduced without the permission of the Consultant

REVISIONS


NO	DESCRIPTION	DATE

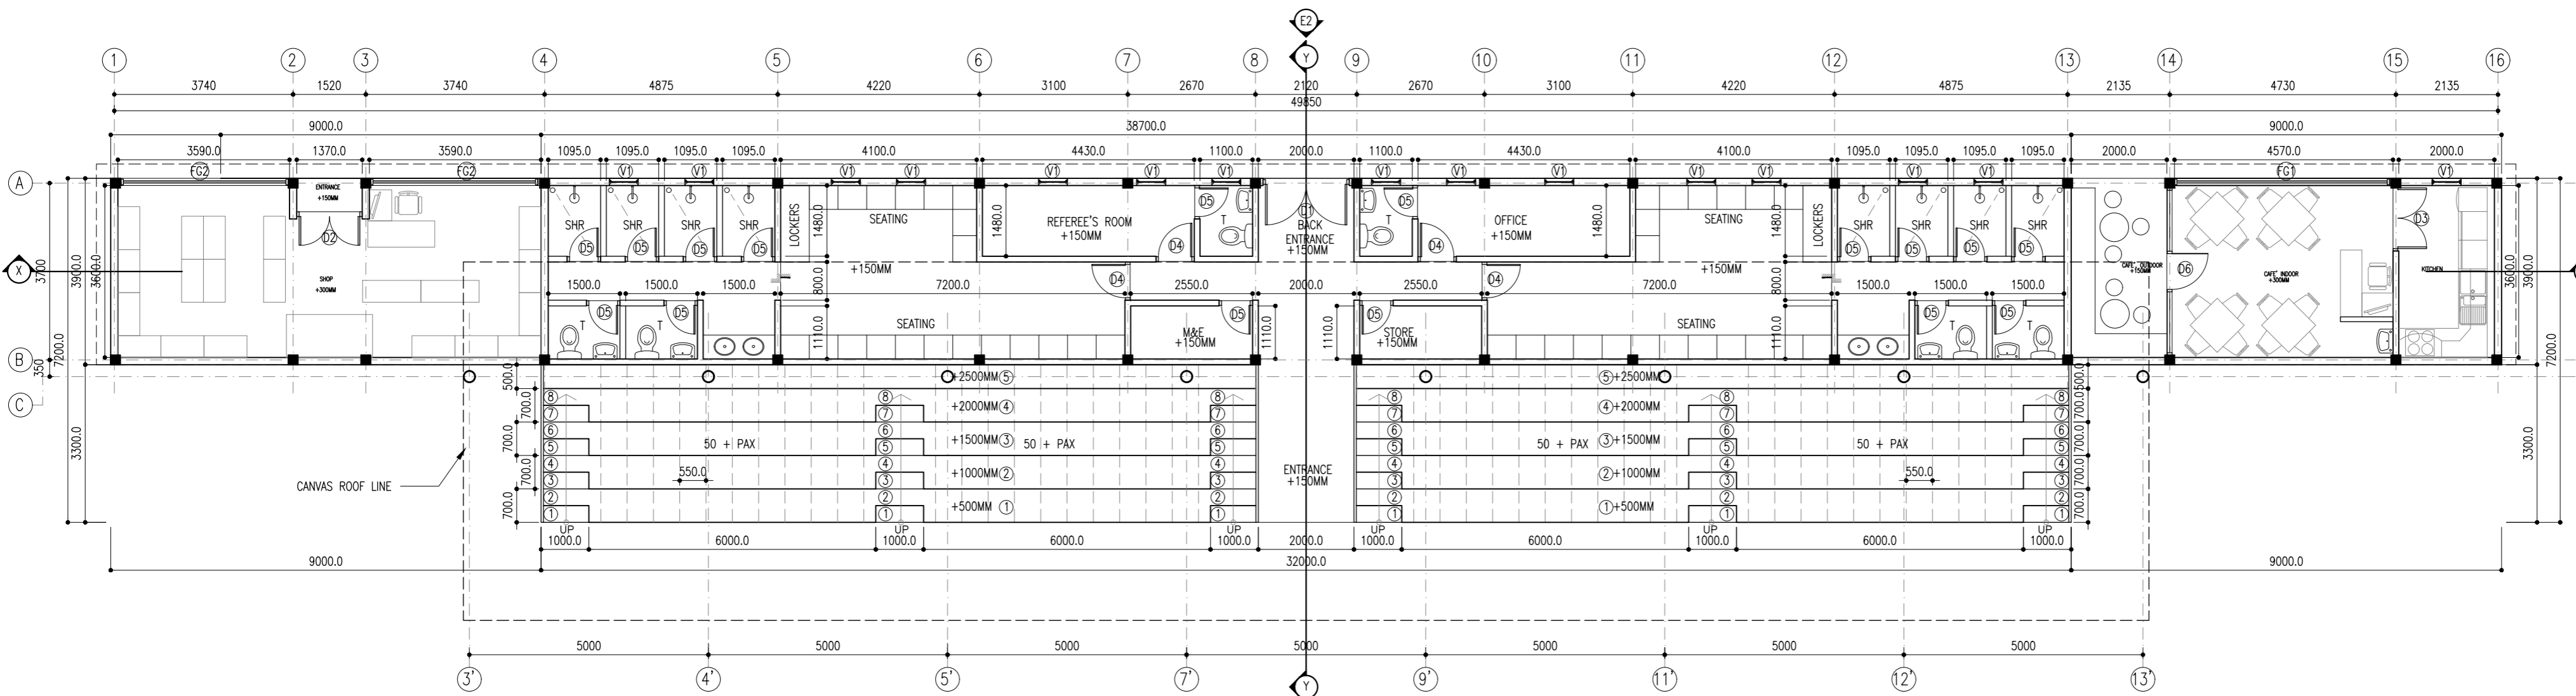

STADIUM SEATING/ CHANGING ROOM/
CAFE/ SHOP FLOOR PLAN
SCALE 1:100

ROOF PLAN
SCALE 1:100



PROJECT:

PROPOSED STADIUM SEATING, CHANGING ROOMS, SHOP, CAFE'

PHASE:

- CONCEPT DESIGN
- DESIGN DEVELOPMENT
- TENDER DOCUMENT
- FOR CONSTRUCTION
- AS BUILD DRAWINGS

DESIGNATION	NAME	SIGNATURE
PROJECT MANAGER	MOHAMED SIRAJ	
STR. ENGINEER	AHMED ZUHAIL	
CHIEF ARCHITECT	MOHAMED SHAMIM	
CHECKED	MOHAMED SIRAJ	
DRAWN	AHUSANA MURUSHI	

DWG. NAME:

ARCHITECTURAL

FLOOR PLAN & ROOF PLAN

CODE	DATE	DWG. NO.
COM-18	01-22-2020	ARO2
FORMAT	A1 A2 A3	
SCALE	- 1:100 -	ISSUE: A
PDF FILE NAME: COM-18_SCF_ARO2A		

CLIENT:
MINISTRY OF YOUTH & SPORTS

DESIGN AND CONSULTANCY:





KEY PLAN:

WARNING:

- This drawing shall not be used for construction unless certified.
- Contractor to verify all dimensions of existing works on site before commencing any work or preparing shop drawings. Do not scale drawings; use written dimensions only.
- This drawing is to be read in conjunction with the specifications and conditions of contract.
- This drawing and design is copyright and no portion may be reproduced without the permission of the Consultant.

REVISIONS

NO	DESCRIPTION	DATE

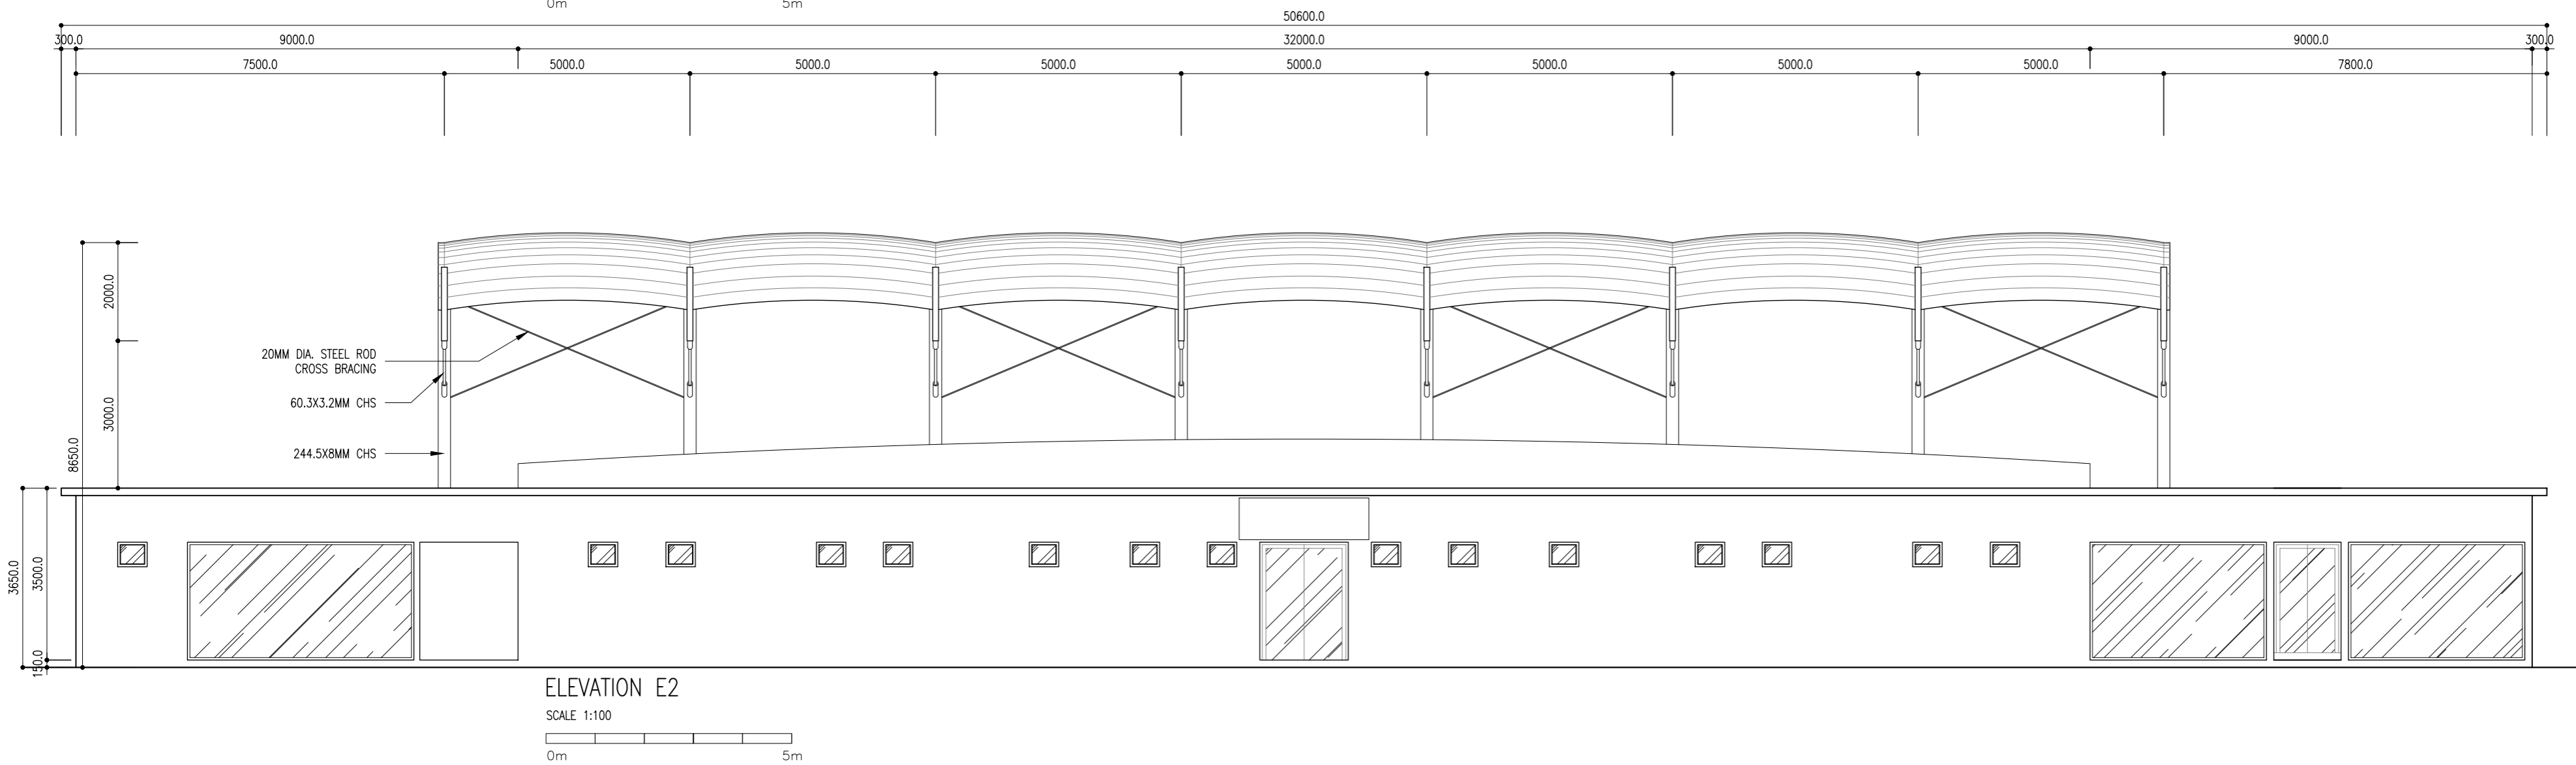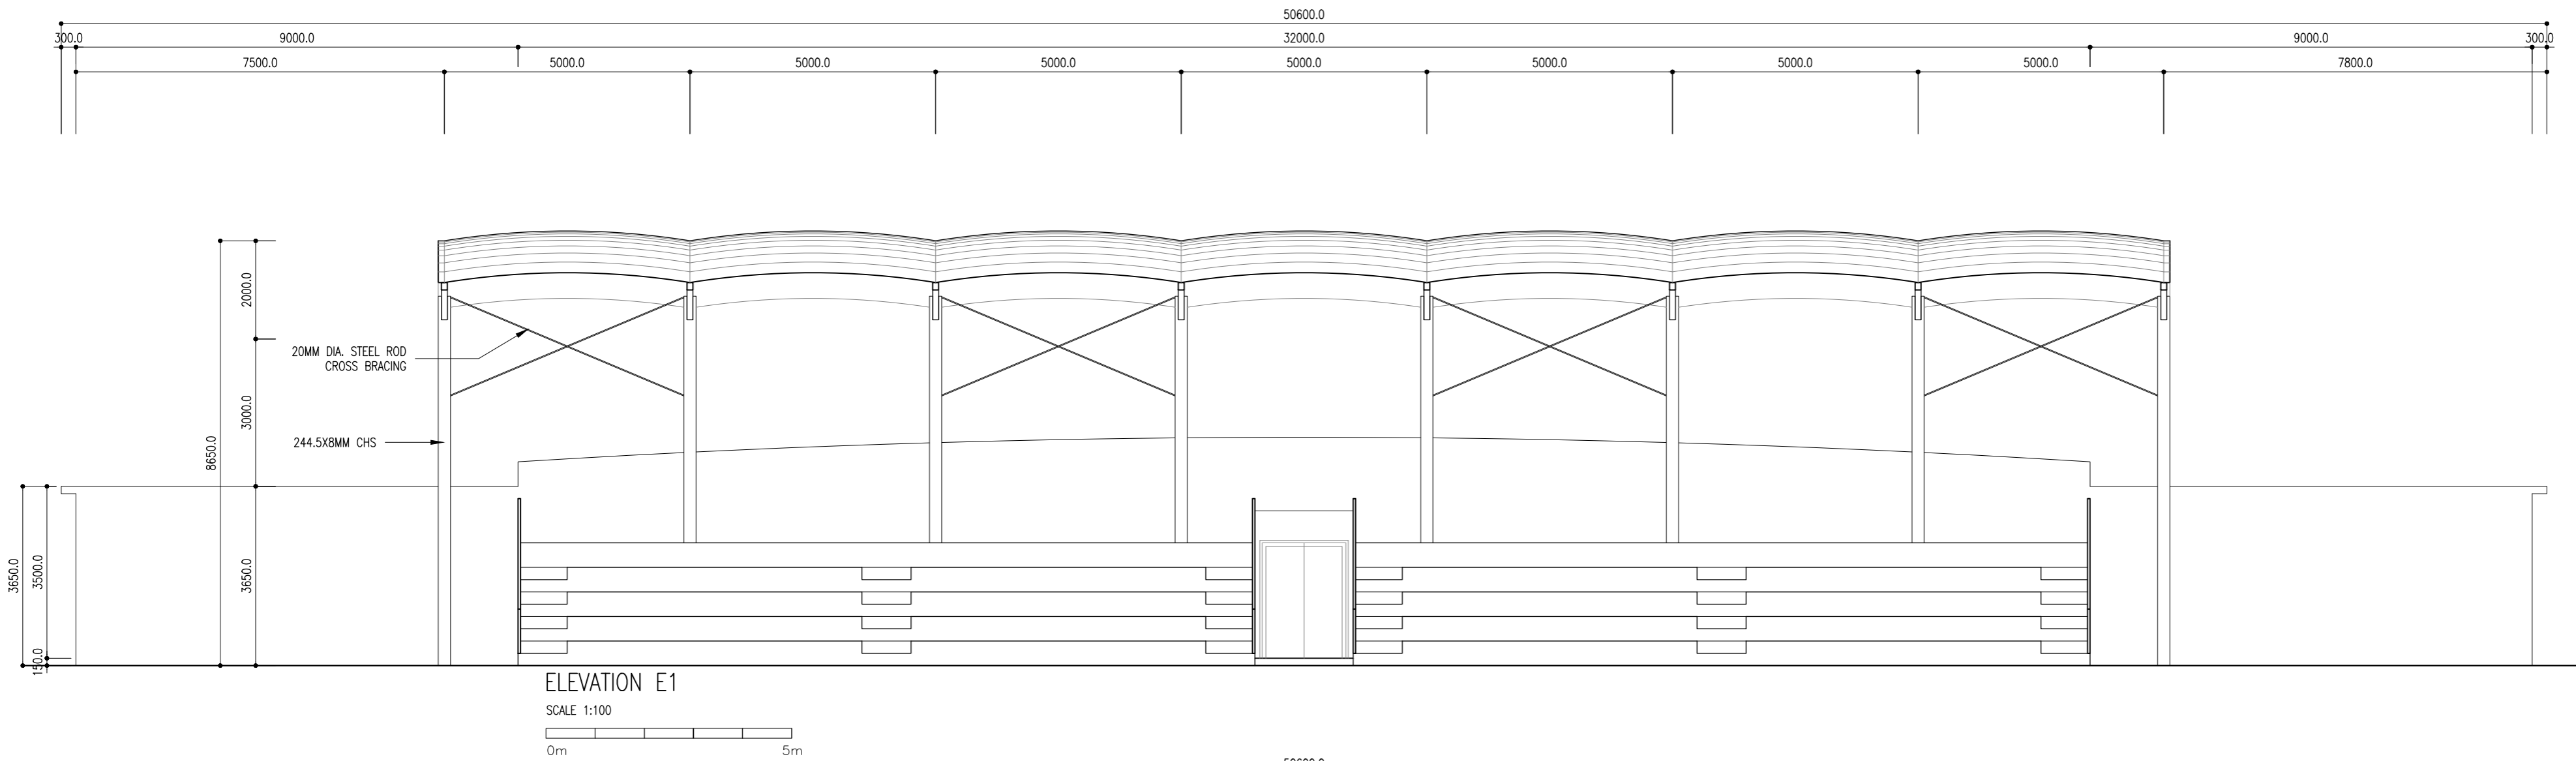

PROJECT:

PROPOSED STADIUM SEATING, CHANGING ROOMS, SHOP, CAFE'

PHASE:

- CONCEPT DESIGN
- DESIGN DEVELOPMENT
- TENDER DOCUMENT
- FOR CONSTRUCTION
- AS BUILD DRAWINGS

DESIGNATION	NAME	SIGNATURE
PROJECT MANAGER	MOHAMED SIRAJ	
STR. ENGINEER	AHMED ZUHAI	
CHIEF ARCHITECT	MOHAMED SHAMIN	
CHECKED	MOHAMED SIRAJ	
DRAWN	AHUSAN ALMURUSRI	

DWG. NAME:

ARCHITECTURAL

ELEVATIONS

CODE	DATE	DWG. NO.
COM-18	01-22-2020	ARO3
FORMAT	A1 A2 A3	
SCALE	- 1:100 -	ISSUE A
PDF FILE NAME: COM-18_SCF_ARO3.A		

CLIENT:
MINISTRY OF YOUTH & SPORTS

DESIGN AND CONSULTANCY:




KEY PLAN:

WARNING:

- This drawing shall not be used for construction unless certified.
- Contractor to verify all dimensions of existing works on site before commencing any work or preparing shop drawings. Do not scale drawings, use written dimensions only.
- This drawing is to be read in conjunction with the specifications and conditions of contract.
- This drawing and design is copyright and no portion may be reproduced without the permission of the Consultant.



REVISIONS

NO	DESCRIPTION	DATE
----	-------------	------

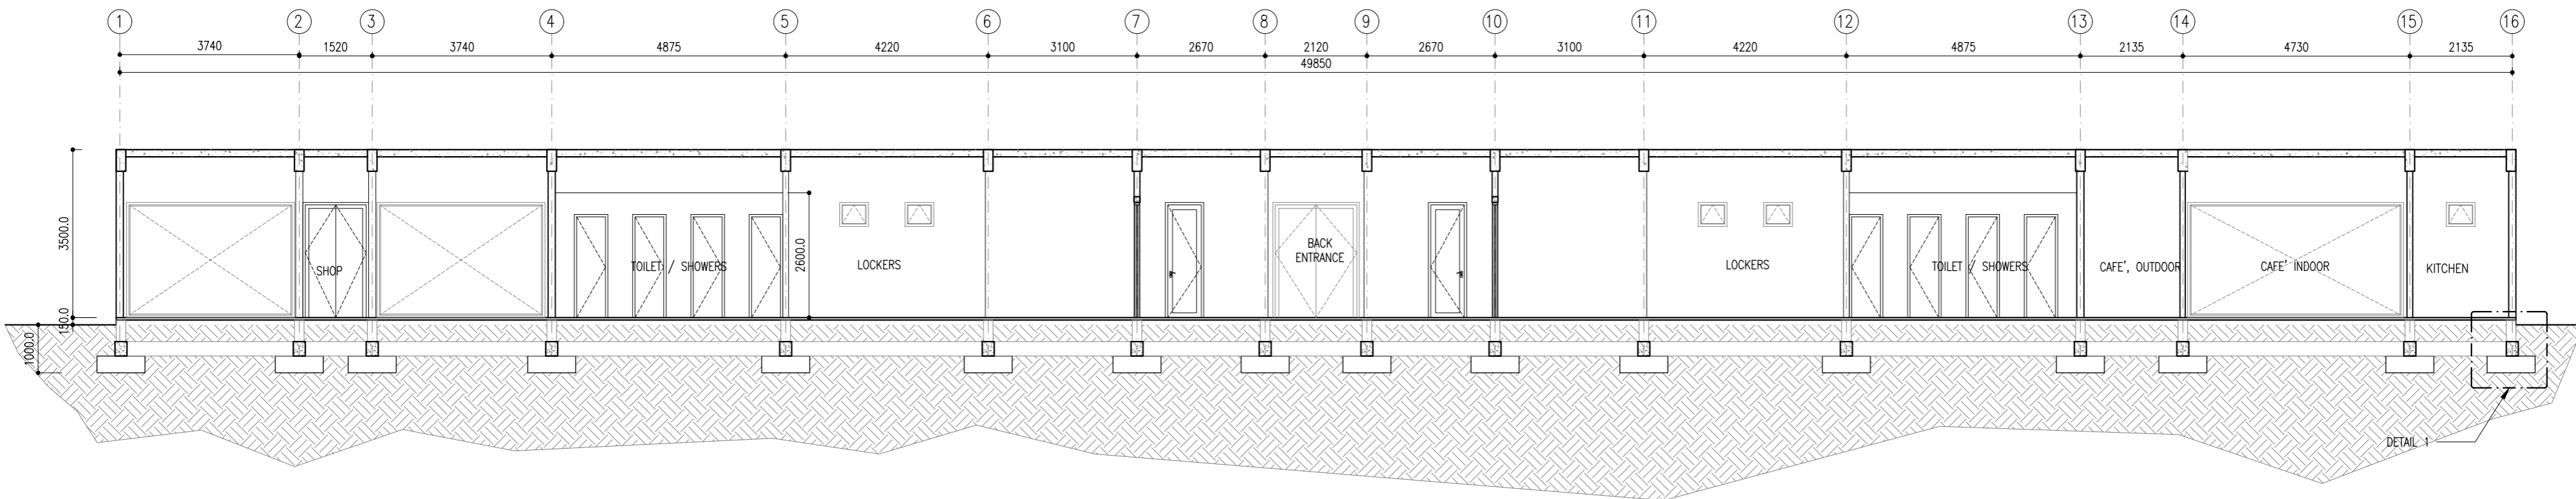

SECTION X-X

 SCALE 1:100

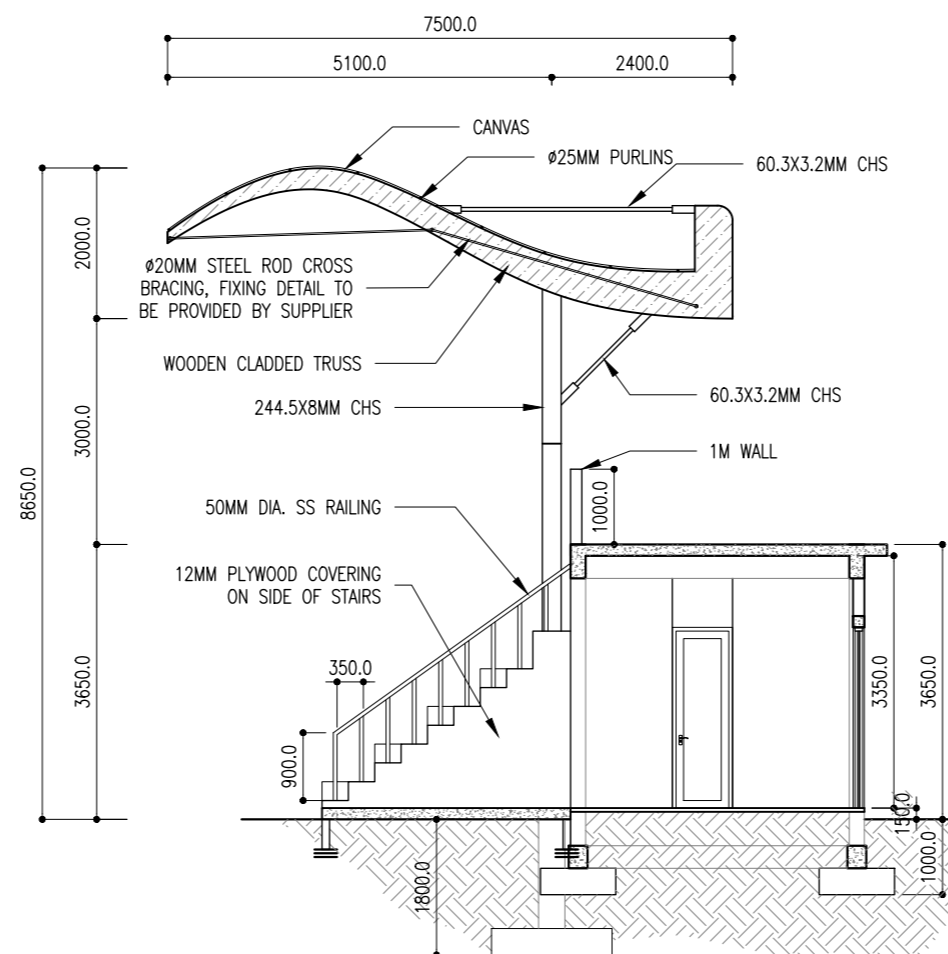

SECTION Y-Y

SCALE 1:100



PROJECT:

PROPOSED STADIUM SEATING, CHANGING ROOMS, SHOP, CAFE'

PHASE:

- CONCEPT DESIGN
- DESIGN DEVELOPMENT
- TENDER DOCUMENT
- FOR CONSTRUCTION
- AS BUILD DRAWINGS

DESIGNATION	NAME	SIGNATURE
PROJECT MANAGER	MOHAMED SIRAJ	
STR. ENGINEER	AHMED ZUHAIL	
CHIEF ARCHITECT	MOHAMED SHAMM	
CHECKED	MOHAMED SIRAJ	
DRAWN	AHUSANA MUKHUSRI	

DWG. NAME:

ARCHITECTURAL

SECTIONS


CODE	DATE	DWG. NO.
COM-18	01-22-2020	ARO4
FORMAT	A1 A2 A3	
SCALE	1:100	ISSUE: A
PDF FILE NAME:	COM-18_SCF_ARO4.A	

- This drawing shall not be used for construction unless certified.
- Contractor to verify all dimensions of existing works on site before commencing any work or preparing shop drawings.
- Do not scale drawings; use written dimensions only.
- This drawing is to be read in conjunction with the specifications and conditions of contract.
- This drawing and design is copyright and no portion may be reproduced without the permission of the Consultant

SYMBOL AREA	D1 TOTAL = 1 nos. G.A. = 4.00 m ²	D2 TOTAL = 1 nos. G.A. = 2.98 m ²	D3 TOTAL = 1 nos. G.A. = 2.98 m ²	D4 TOTAL = 04 nos. G.A. = 1.65 m ²	D5 TOTAL = 16 nos. G.A. = 1.26 m ²
PLAN					
ELEVATION					
FLR LVL					
LOCATION	CHANGING ROOM MAIN ENTRANCE	SHOP ENTRANCE	KITCHEN ENTRANCE	CHANGING ROOM, REFEREE'S ROOM, OFFICE ENTRANCE	TOILETS, SHOWERS, STORE, M&E
QUANTITY	01	01	01	04	16
DOOR FRAME	POWDER COATED ALUMINUM FRAME	POWDER COATED ALUMINUM FRAME	TIMBER, NYATOH OR EQUIVALENT	POWDER COATED ALUMINUM FRAME	TIMBER, NYATOH OR EQUIVALENT
DOOR PANEL	POWDER COATED ALUMINUM WITH 6MM FLOAT GLASS	POWDER COATED ALUMINUM WITH 6MM FLOAT GLASS	TIMBER PANEL WITH FIXED GLASS	FIXED GLASS PANEL	TIMBER PANEL
LOCK/HINGES	BRUSHED METAL (SILVER) HANDLE X 3 LOCK X 1	BRUSHED METAL (SILVER) HANDLE X 3 LOCK X 1	BRUSHED METAL (SILVER) HANDLE X 3 LOCK X 1	1 BRUSHED METAL (SILVER) HANDLE + 3 HINGES + 1 LOCK	BUTT HINGE (SILVER) X 4 KNOB LOCKSET X 1
FINISHES	WHITE FINISH	WHITE FINISH	WOOD STAIN FINISH	POWDER COATED WHITE FINISH	WOOD STAIN FINISH
REMARKS	TINTED GLASS	TINTED GLASS	TINTED GLASS		

SYMBOL AREA	D6 TOTAL = 1 nos. G.A. = 1.88 m ²	FG1 TOTAL = 1 nos. G.A. = 0.00 m ²	FG2 TOTAL = 2 nos. G.A. = 0.00 m ²	V1 TOTAL = 15 nos. G.A. = 0.20 m ²
PLAN				
ELEVATION				
FLR LVL				
LOCATION	CAFE'	CAFE'	SHOP	CHANGING ROOMS, KITCHEN
QUANTITY	1	1	2	15
DOOR FRAME	80 MICRON WHITE POWDER COATED ALUMINUM FRAME	80 MICRON WHITE POWDER COATED ALUMINUM FRAME	80 MICRON WHITE POWDER COATED ALUMINUM FRAME	POWDER COATED ALUMINUM FRAME
DOOR PANEL	POWDER COATED ALUMINUM WITH 6MM CLEAR GLASS	POWDER COATED ALUMINUM WITH 6MM CLEAR GLASS	POWDER COATED ALUMINUM WITH 6MM CLEAR GLASS	POWDER COATED ALUMINUM BOARD WITH 6MM FLOAT GLASS
LOCK/HINGES	1 BRUSHED METAL (SILVER) HANDLE + 3 HINGES + 1 LOCK	-	-	BRUSHED METAL (SILVER) X 3 LOCK X 1
FINISHES	POWDER COATED WHITE FINISH	POWDER COATED WHITE FINISH	POWDER COATED WHITE FINISH	WHITE FINISH
REMARKS	FIXED GLASS & A GLASS DOOR	FIXED GLASS	FIXED GLASS	TINTED GLASS

 DOOR & WINDOW SCHEDULE



NOTE:

G: 6mm thk glazing
FG: 6mm thk fixed glazing
PP: 35mm thk H/W framed ply door panel
T: Timber

- CONCEPT DESIGN
- DESIGN DEVELOPMENT
- TENDER DOCUMENT
- FOR CONSTRUCTION
- AS BUILD DRAWINGS

DESIGNATION	NAME	SIGNATURE
PROJECT MANAGER	MOHAMED SIRAJ	
STR. ENGINEER	AHMED ZUHAIL	
CHEF ARCHITECT	MOHAMED SHAMIN	
CHECKED	MOHAMED SIRAJ	
DRAWN	AHUSANA.MUHUSIN	


CODE	DATE	DWG. NO.
COM-18	01-22-2020	AR05
FORMAT	A1 A2 A3	
SCALE	1:100	ISSUE A
PDF FILE NAME:	COM-18_SCF_AR05A	

WARNING:

- This drawing shall not be used for construction unless certified.
- Contractor to verify all dimensions of existing works on site before commencing any work or preparing shop drawings. Do not scale drawings; use written dimensions only.
- This drawing is to be read in conjunction with the specifications and conditions of contract.
- This drawing and design is copyright and no portion may be reproduced without the permission of the Consultant.

REVISIONS

NO	DESCRIPTION	DATE
----	-------------	------

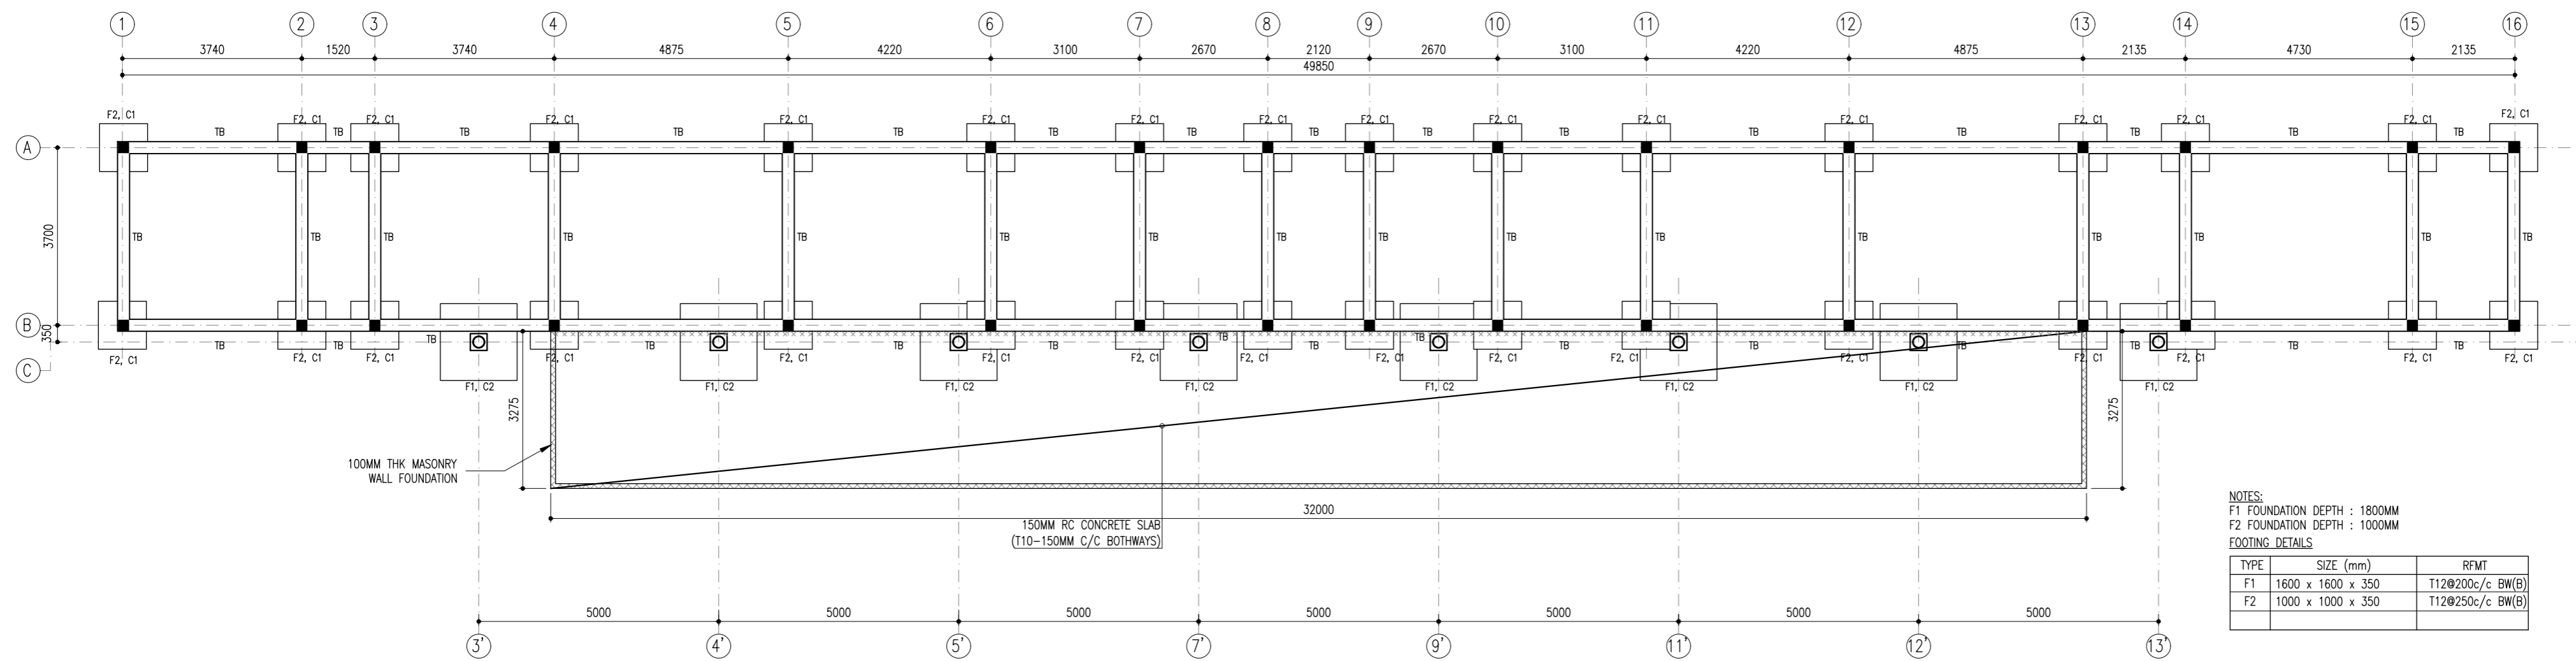


NOTES:
 F1 FOUNDATION DEPTH : 1800MM
 F2 FOUNDATION DEPTH : 1000MM
 FOOTING DETAILS

TYPE	SIZE (mm)	RFMT
F1	1600 x 1600 x 350	T12@200c/c BW(B)
F2	1000 x 1000 x 350	T12@250c/c BW(B)


FOUNDATION & COLUMN LOCATION PLAN

SCALE 1:100

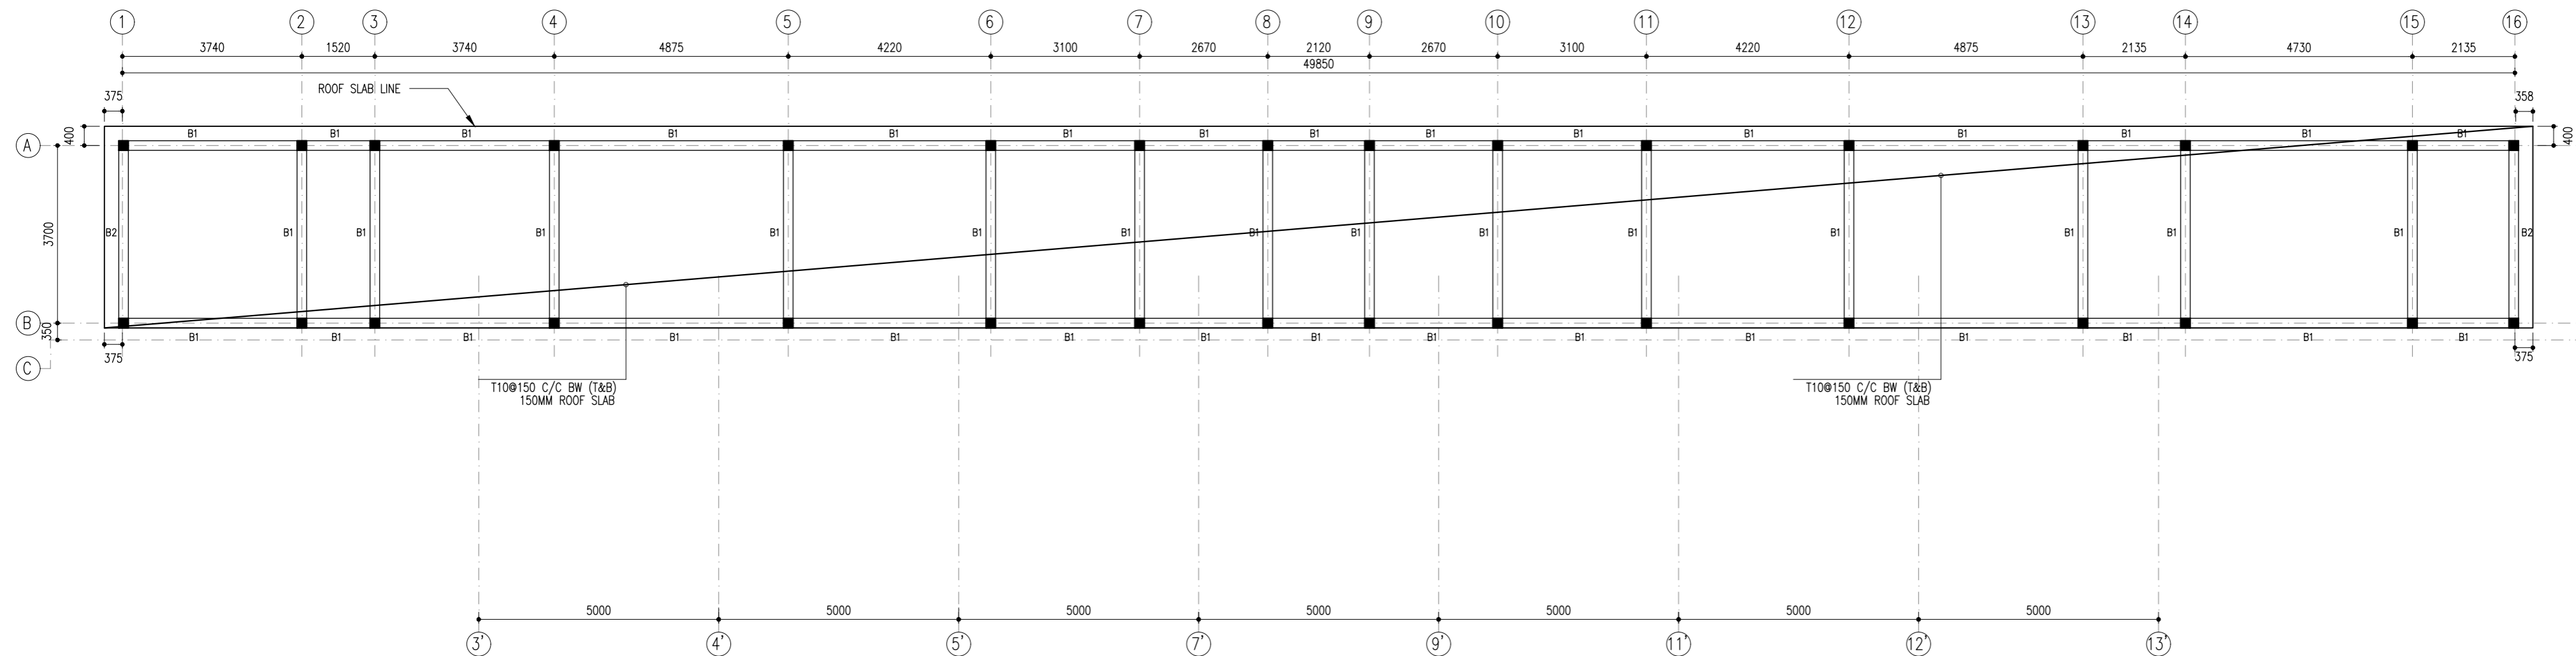

ROOF BEAM & SLAB PLAN

 SCALE 1:100



PROJECT:

PROPOSED STADIUM SEATING, CHANGING ROOMS, SHOP, CAFE'

PHASE:

- CONCEPT DESIGN
- DESIGN DEVELOPMENT
- TENDER DOCUMENT
- FOR CONSTRUCTION
- AS BUILD DRAWINGS

DESIGNATION	NAME	SIGNATURE
PROJECT MANAGER	MOHAMED SIRAJ	
STR. ENGINEER	AHMED ZUHAIL	
CHIEF ARCHITECT	MOHAMED SHAMM	
CHECKED	MOHAMED SIRAJ	
DRAWN	AHUSANA.MUHSIN	

DWG. NAME:

STRUCTURAL

FOUNDATION, COLUMN, ROOF BEAM & SLAB PLAN


CODE	DATE	DWG. NO:
COM-18	01-22-2020	ST01
FORMAT	A1 A2 A3	
SCALE	1:100	ISSUE A
PDF FILE NAME: COM-18_SCF_ST01A		

KEY PLAN:

WARNING:

- This drawing shall not be used for construction unless certified.
- Contractor to verify all dimensions of existing works on site before commencing any work or preparing shop drawings.
- Do not scale drawings; use written dimensions only.
- This drawing is to be read in conjunction with the specifications and conditions of contract.
- This drawing and design is copyright and no portion may be reproduced without the permission of the Consultant

REVISIONS		
NO	DESCRIPTION	DATE

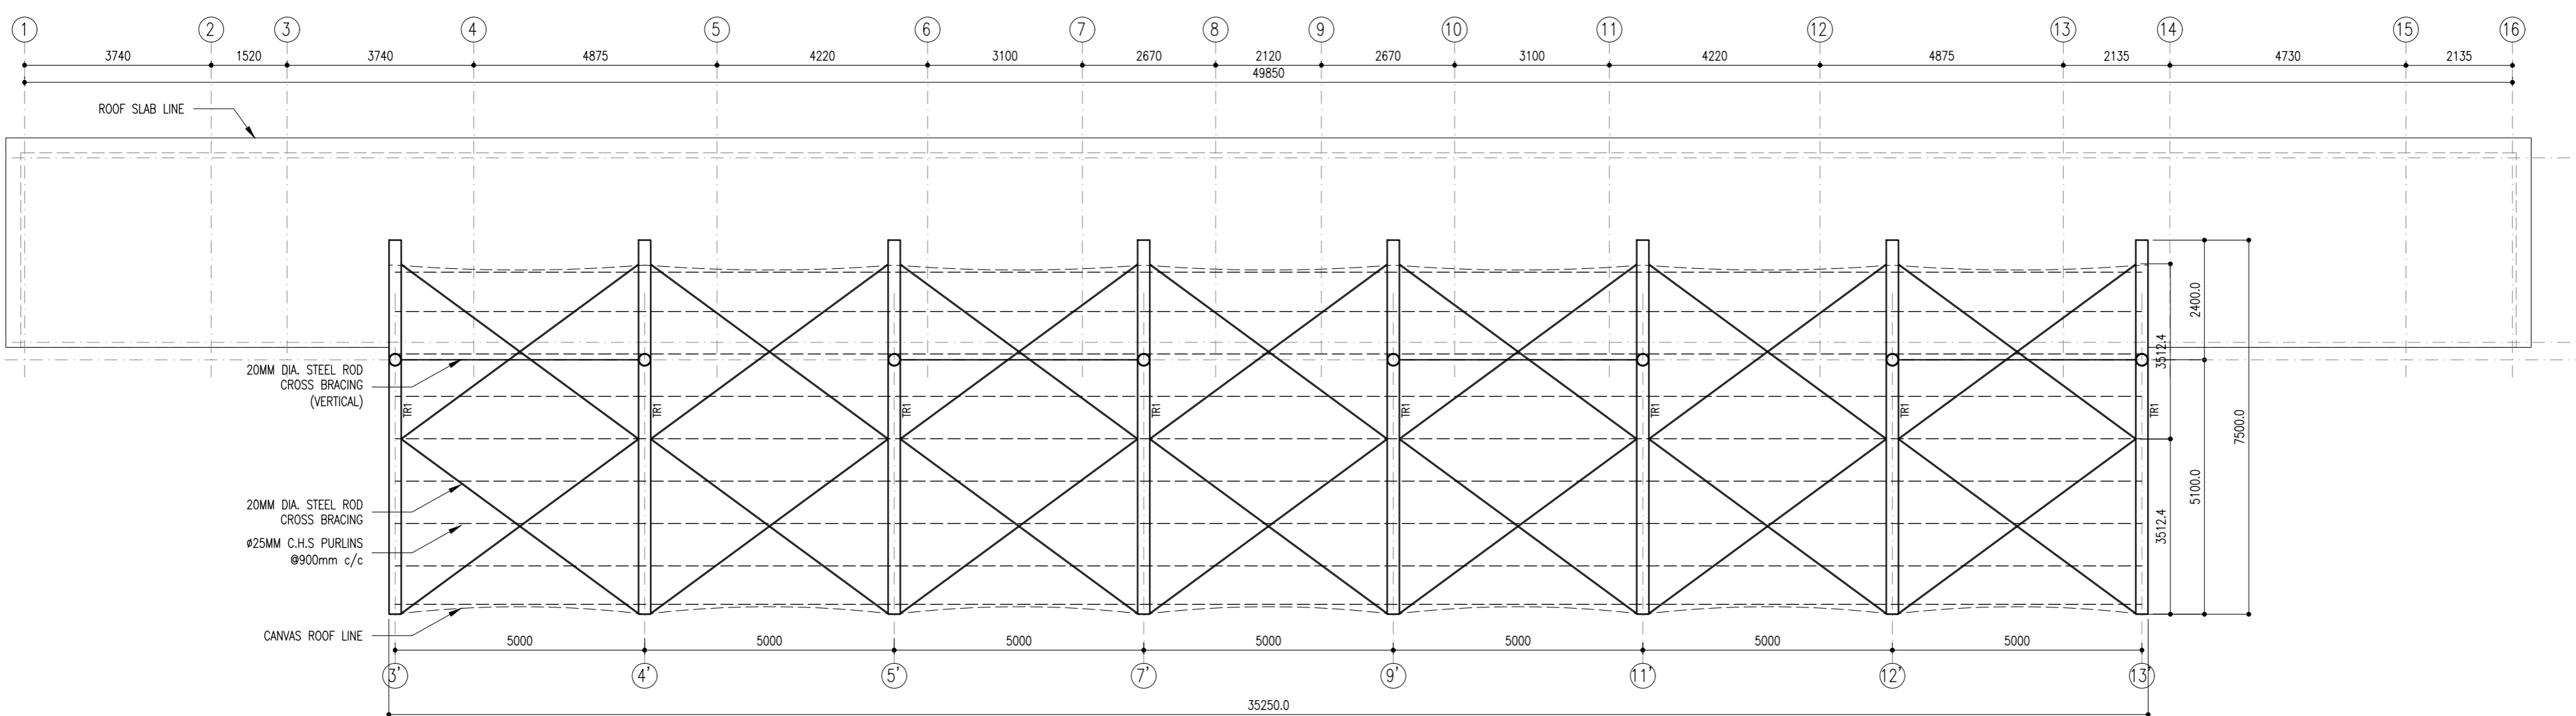

20MM DIA. STEEL ROD CROSS BRACING (VERTICAL)


20MM DIA. STEEL ROD CROSS BRACING

#25MM C.H.S. PURLINS @900mm c/c

CANVAS ROOF LINE

CANVAS ROOF STRUCTURE PLAN

 SCALE 1:100



PROJECT:
PROPOSED STADIUM SEATING, CHANGING ROOMS, SHOP, CAFE'

PHASE:
 CONCEPT DESIGN
 DESIGN DEVELOPMENT
 TENDER DOCUMENT
 FOR CONSTRUCTION
 AS BUILD DRAWINGS

DESIGNATION	NAME	SIGNATURE
PROJECT MANAGER	MOHAMED SIRAJ	
STR. ENGINEER	AHMED ZUHAIL	
CHEF ARCHITECT	MOHAMED SHAMM	
CHECKED	MOHAMED SIRAJ	
DRAWN	AHUSANA MUHUSNI	

DWG. NAME:
STRUCTURAL

CANVAS ROOF STRUCTURE PLAN



CODE	DATE	DWG. NO.
COM-18	01-22-2020	ST02
FORMAT	A1 A2 A3	
SCALE	1:100	ISSUE A
PDF FILE NAME:	COM-18_SCF_ST02_A	

KEY PLAN:



WARNING:

- This drawing shall not be used for construction unless certified.
 - Contractor to verify all dimensions of existing works on site before commencing any work or preparing shop drawings. Do not scale drawings; use written dimensions only.
 - This drawing is to be read in conjunction with the specifications and conditions of contract.
 - This drawing and design is copyright and no portion may be reproduced without the permission of the Consultant.


REVISIONS		
NO	DESCRIPTION	DATE

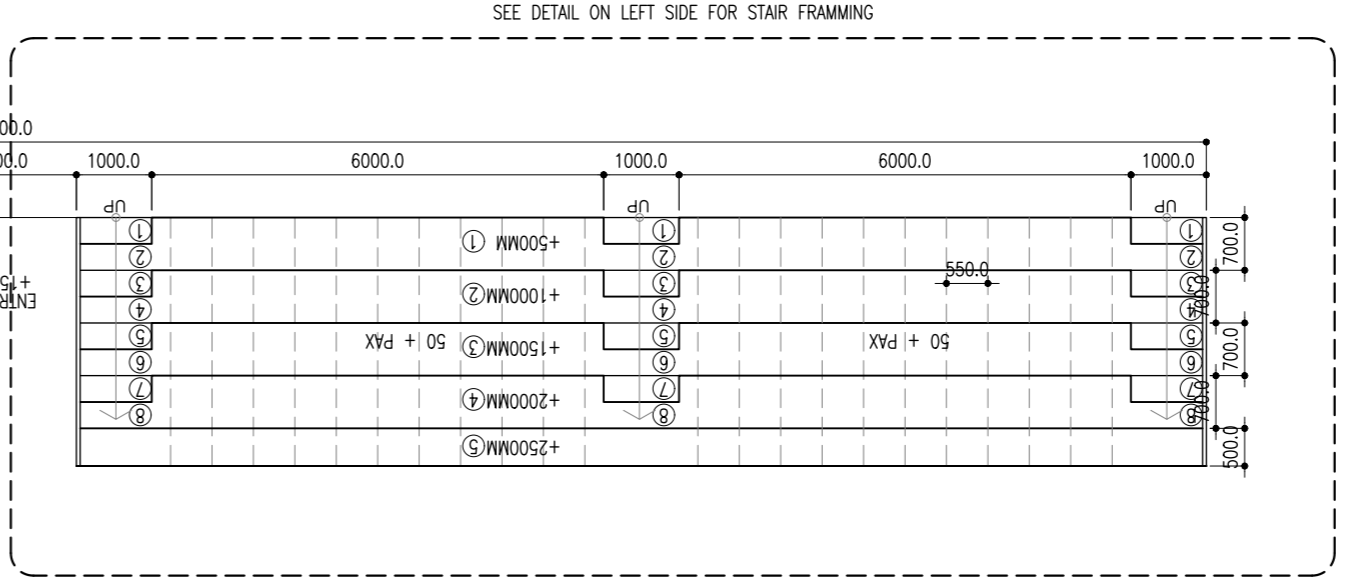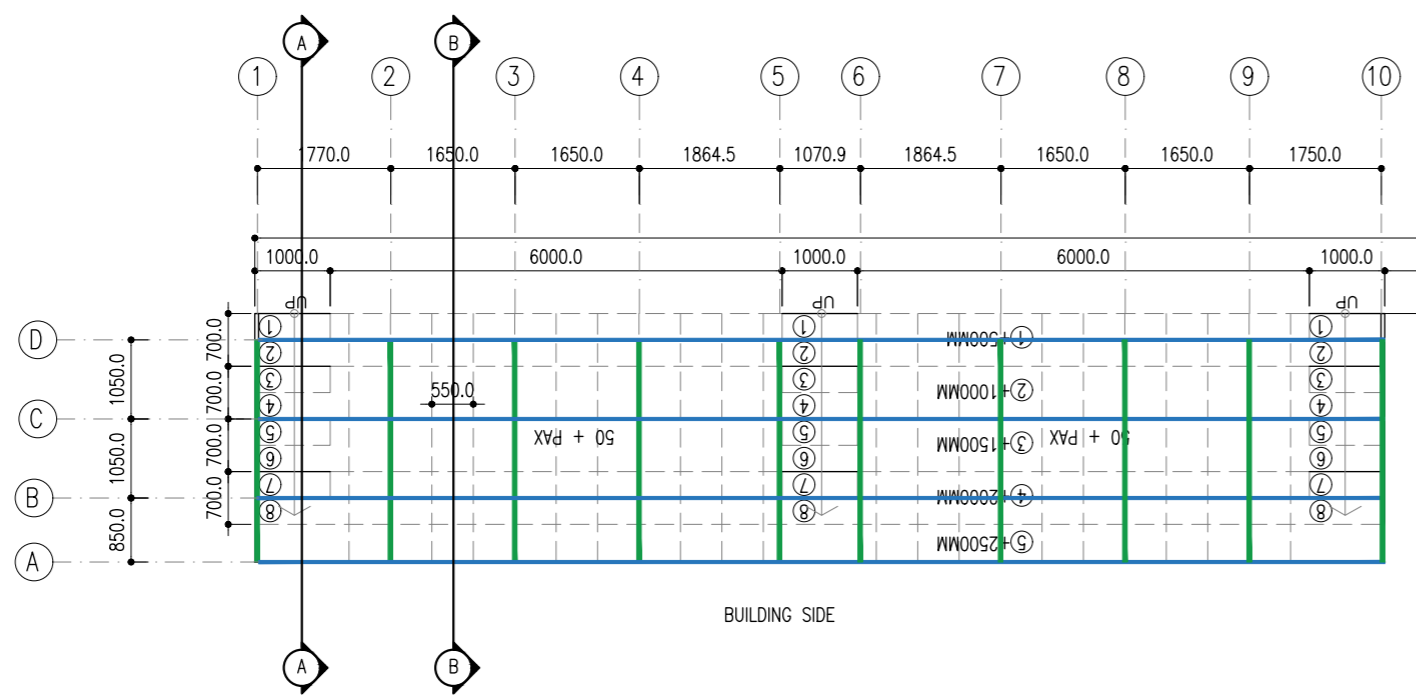


STAIR FRAME LAYOUT
SCALE 1:100

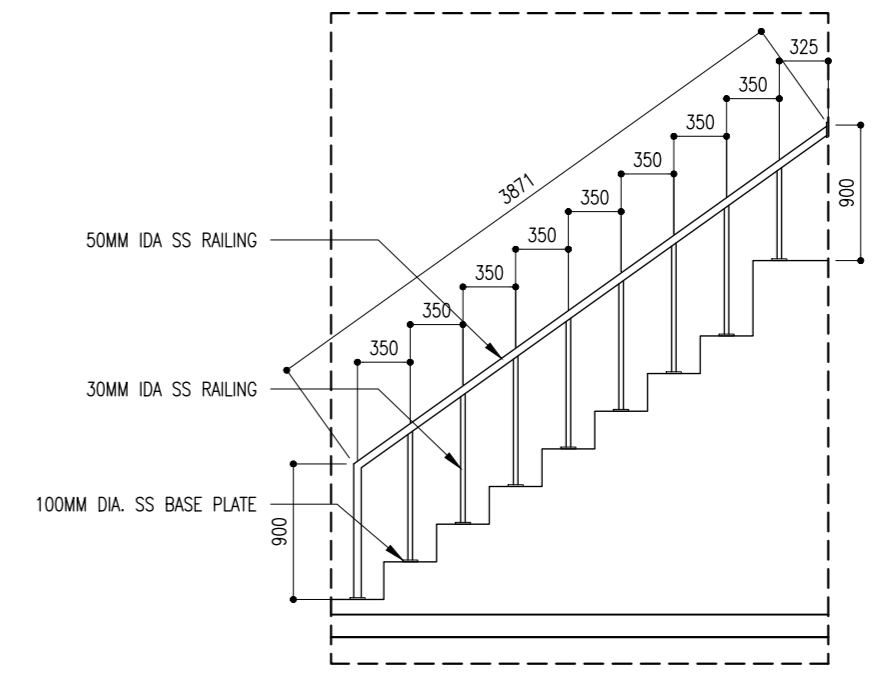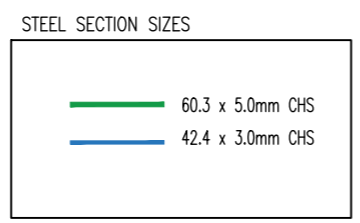


RAILING DETAILS
SCALE 1: 50

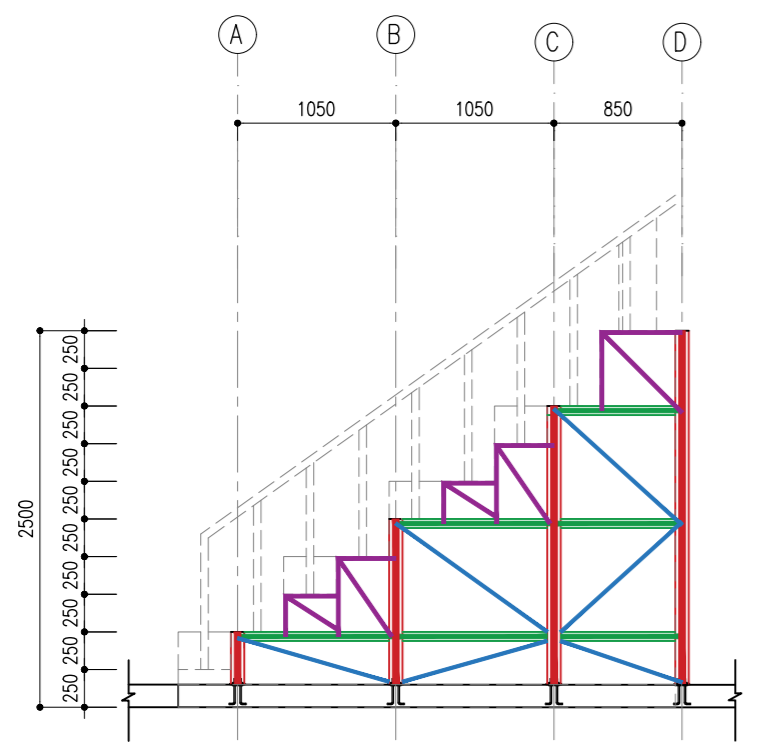


STAIR FRAME LAYOUT (SECTION A)
SCALE 1: 50

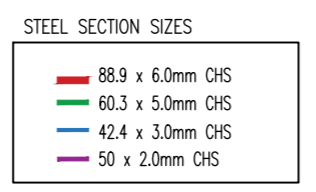

SUPPLIER SHALL PROVIDE ALL THE JOINT AND CONNECTION DETAILS PRIO FABRICATION

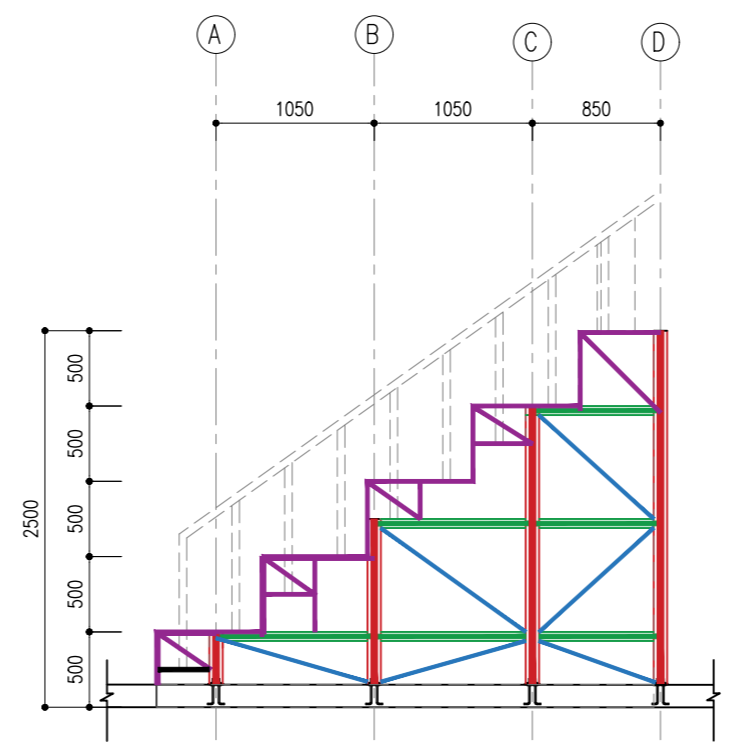

STAIR FRAME LAYOUT (SECTION B)
SCALE 1: 50

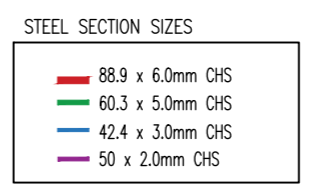

SUPPLIER SHALL PROVIDE ALL THE JOINT AND CONNECTION DETAILS PRIO FABRICATION

PROJECT:
PROPOSED STADIUM SEATING, CHANGING ROOMS, SHOP, CAFE'

PHASE:


- CONCEPT DESIGN
- DESIGN DEVELOPMENT
- TENDER DOCUMENT**
- FOR CONSTRUCTION
- AS BUILD DRAWINGS

DESIGNATION	NAME	SIGNATURE
PROJECT MANAGER	MOHAMED SIRAJ	
STR. ENGINEER	AHMED ZUHAIL	
CHIEF ARCHITECT	MOHAMED SHAMM	
CHECKED	MOHAMED SIRAJ	
DRAWN	AHUSAN ALMUSLIM	

DWG. NAME:
STRUCTURAL

STAIR DETAILS

CODE	DATE	DWG. NO.
COM-18	01-22-2020	ST03
FORMAT	A1 A2 A3	
SCALE	- 1/50 -	ISSUE: A
PDF FILE NAME: COM-18_SCF_ST03.A		

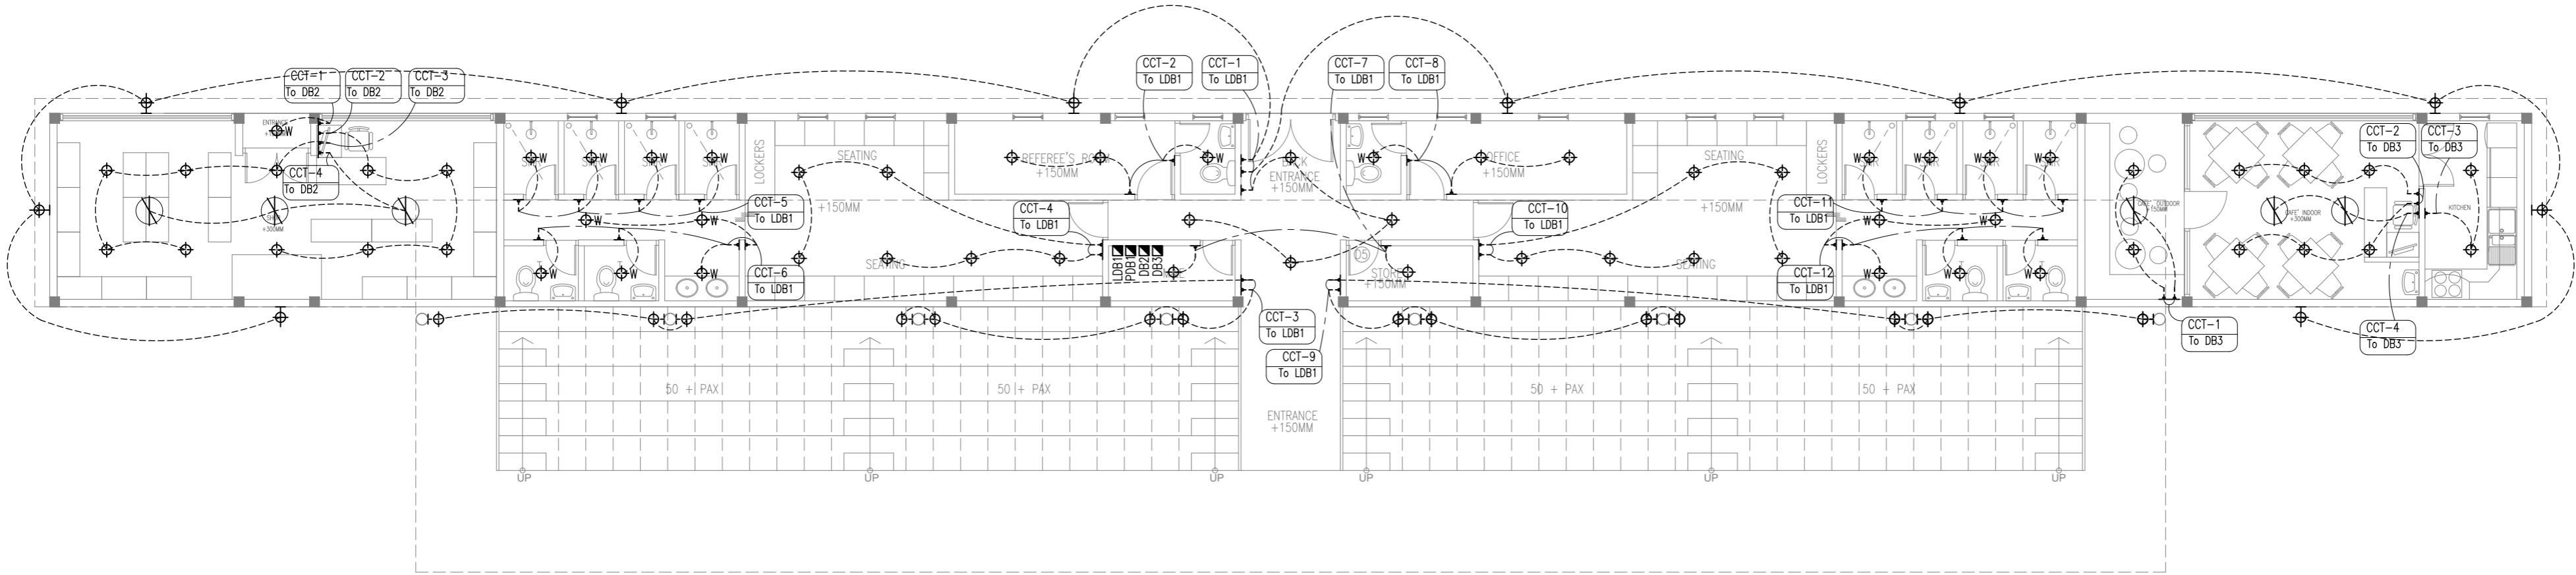


ELECTRICAL LIGHTING LAYOUT
SCALE 1:100

LEGEND

	CEILING LIGHT		WALL SOCKET 15A (WATER HEATER)		CABLE TV SOCKET OUTLET		WEATHERPROOF
	SPOT LIGHT		ONE-WAY SWITCH / FAN CONTROL		CEILING FAN		MAINS
	WEATHER PROOF OUTDOOR LIGHT		EXHAUST FAN		DOOR PHONE		DOOR ACCESS PANEL
	WALL SOCKET 13A (LOW LVL)		WALL SOCKET 15A (AIR-CON)		D-BOARD		STRIP LIGHT
	WALL SOCKET 13A (HIGH LVL)		TELEPHONE/NETWORK SOCKET		AC INDOOR UNIT		FLOOR LIGHT
	WALL SOCKET 15A (LOW LVL)						

NOTE:
THE DRAWINGS ARE SCHEMATIC. DETAILED SYSTEMS DESIGN AND CONDUITING SHALL BE DONE BY CONTRACTOR AND SUBMITTED FOR APPROVAL BEFORE INSTALLATION.

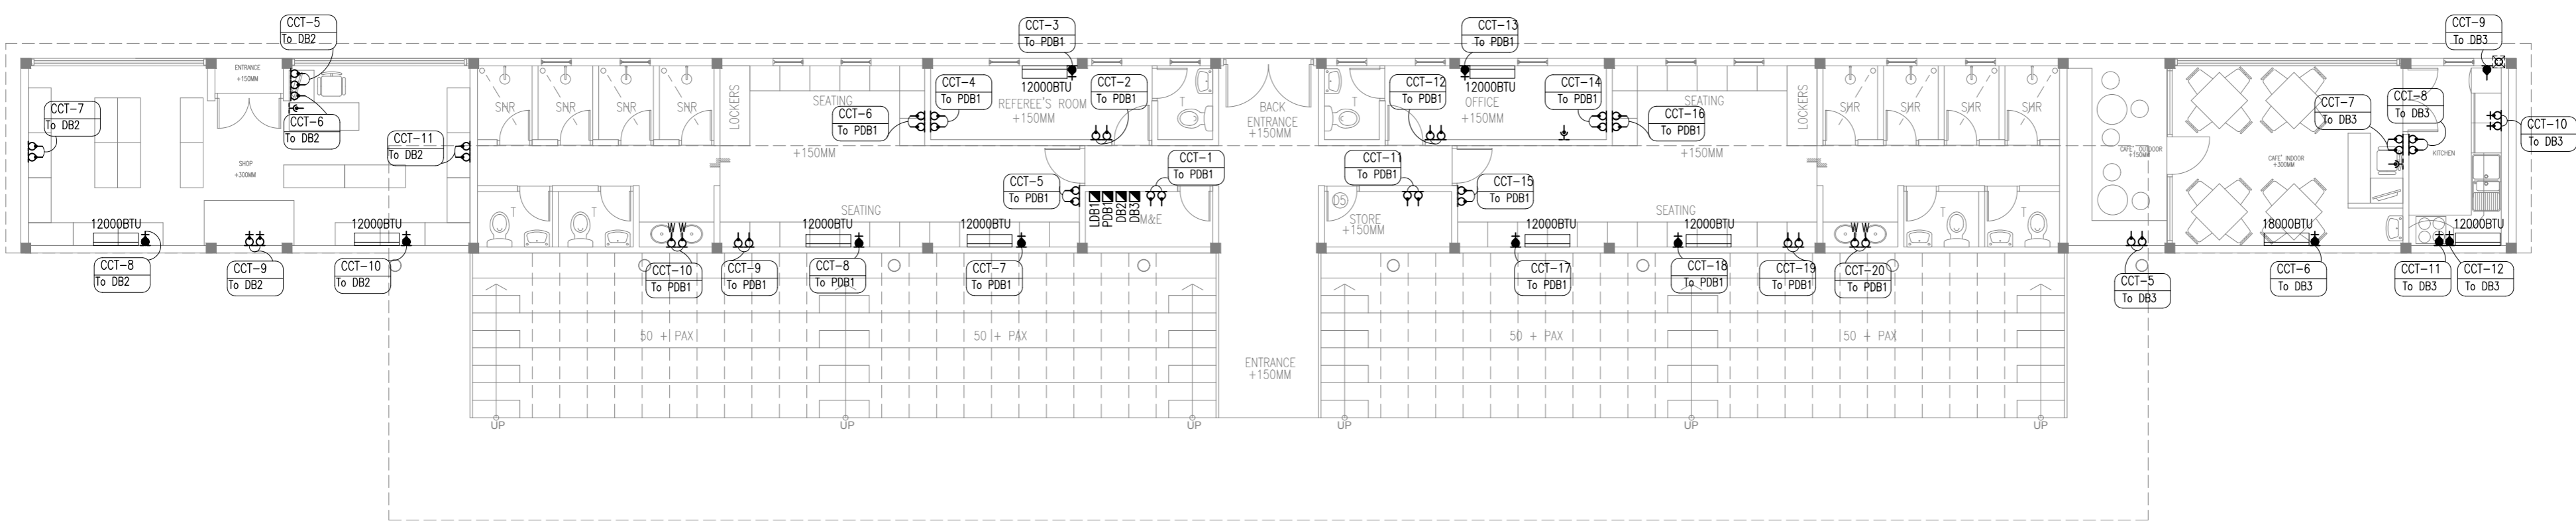

POWER SOCKETS & AC LAYOUT
SCALE 1:100

DESIGNATION	NAME	SIGNATURE
PROJECT MANAGER	MUHAMMAD SIRAJ	
STR. ENGINEER	AHMED ZUHAIL	
CHEF ARCHITECT	MUHAMMAD SHAMIM	
CHECKED	MUHAMMAD SIRAJ	
DRAWN	AHUSANA MUMTHASIR	

