


SITE PLAN

SCALE: 1 : 100

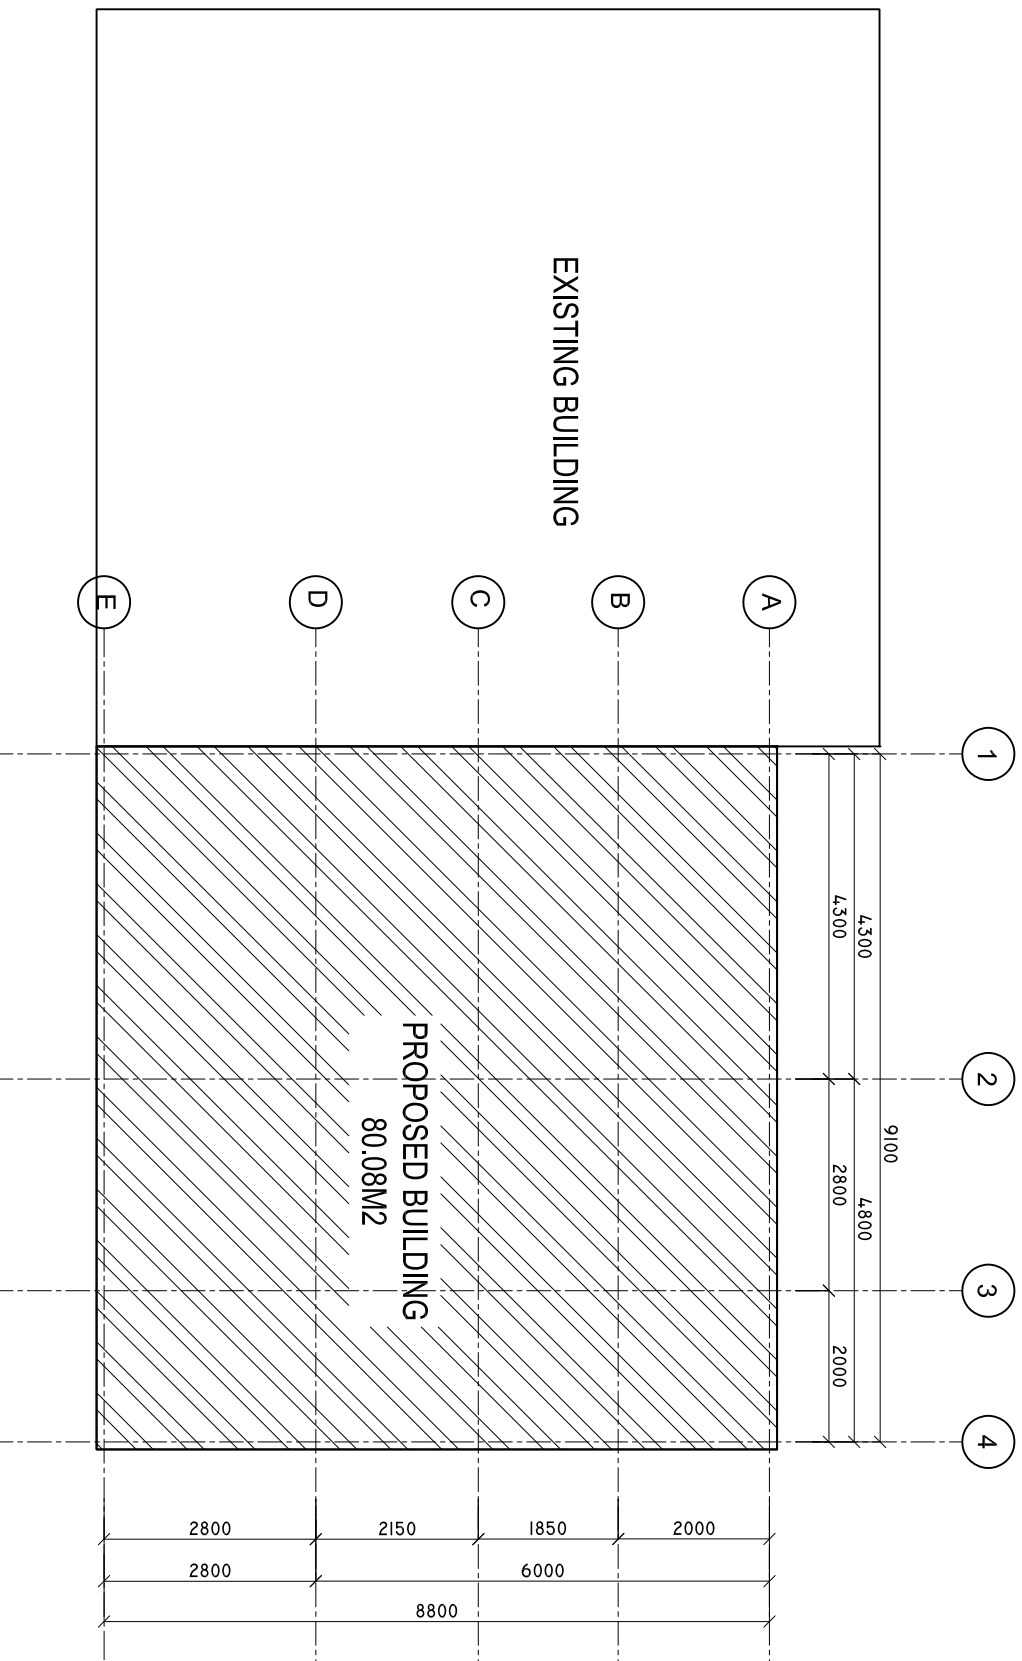

SHEET CONTENTS :

REVISION NOTES:

PROJECT:
EXTENSION OF ADH,
MANDHOO HEALTH
CENTER.

CLIENT:
MINISTRY OF HEALTH

LOCATION:
ADH, MANDHOO

CONTENTS: AS GIVEN

PROJECT MANAGER:

DESIGNER: ARIZ

CIV/STR. ENGINEER:

SURVEYED BY: -

DRAWN BY: ARIZ

CHECKED BY:

DATE : FEBRUARY 2021

SHEET NO. : /


PAPER SIZE: A3



ADMIN DIVISION
Ministry of Health
Roshan-e Building
Sasana Margu
Tel: 332 8887, Fax: 332 8889

FLOOR PLAN

SCALE: 1 : 100

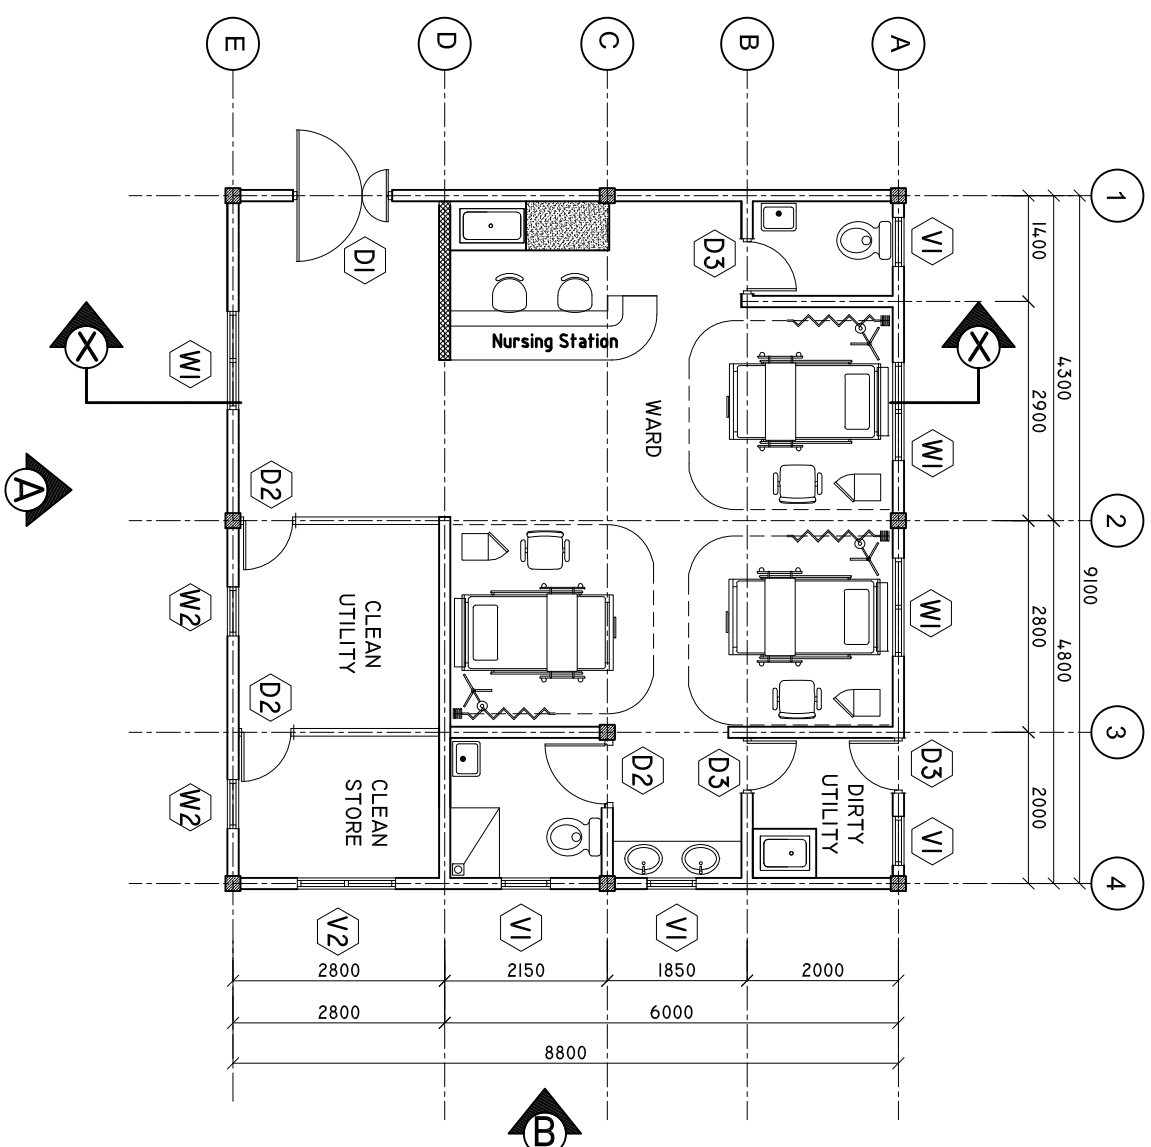

150MM THICK HOLLOW BLOCK MASONRY WALL,
1000MM FROM FLOOR FINISH LEVEL

SHEET CONTENTS :

REVISION NOTES:

PROJECT:
EXTENSION OF ADH,
MANDHOO HEALTH
CENTER.

CLIENT:
MINISTRY OF HEALTH

LOCATION:
ADH, MANDHOO

CONTENTS: AS GIVEN

PROJECT MANAGER:

DESIGNER: ARIZ

CIV/STR. ENGINEER:

SURVEYED BY: -

DRAWN BY: ARIZ

CHECKED BY:

DATE : FEBRUARY 2021


SHEET NO. : /

PAPER SIZE: A3



FLOOR PLAN INCLUDING EXISTING BUILDING

SCALE: 1 : 100

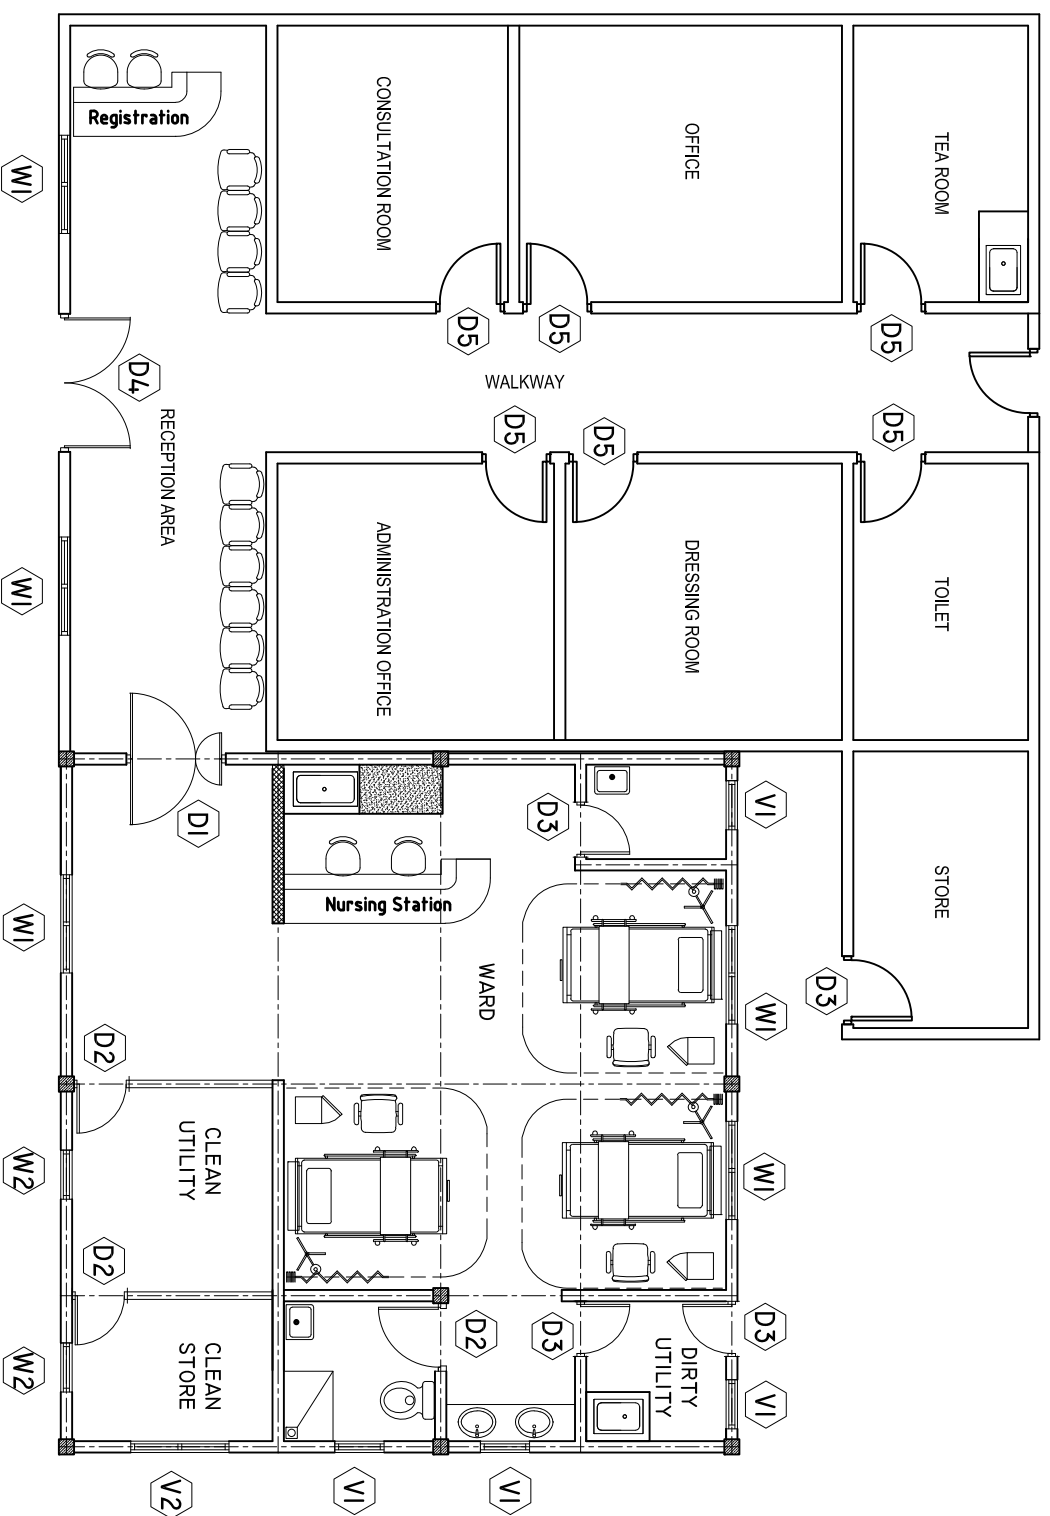

SHEET CONTENTS :

REVISION NOTES:

PROJECT:
EXTENSION OF ADH,
MANDHOO HEALTH
CENTER.

CLIENT:
MINISTRY OF HEALTH

LOCATION:
ADH , MANDHOO

CONTENTS: AS GIVEN

PROJECT MANAGER:

DESIGNER: ARIZ

CIV/STR. ENGINEER:

SURVEYED BY: -

DRAWN BY: ARIZ

CHECKED BY:

DATE : FEBRUARY 2021

SHEET NO. : /


PAPER SIZE: A3



ADMIN DIVISION
Ministry of Health
Roshanra Building
Soan Marg
Tel: 332 8887, Fax: 3328889

ROOF PLAN

SCALE: 1 : 100

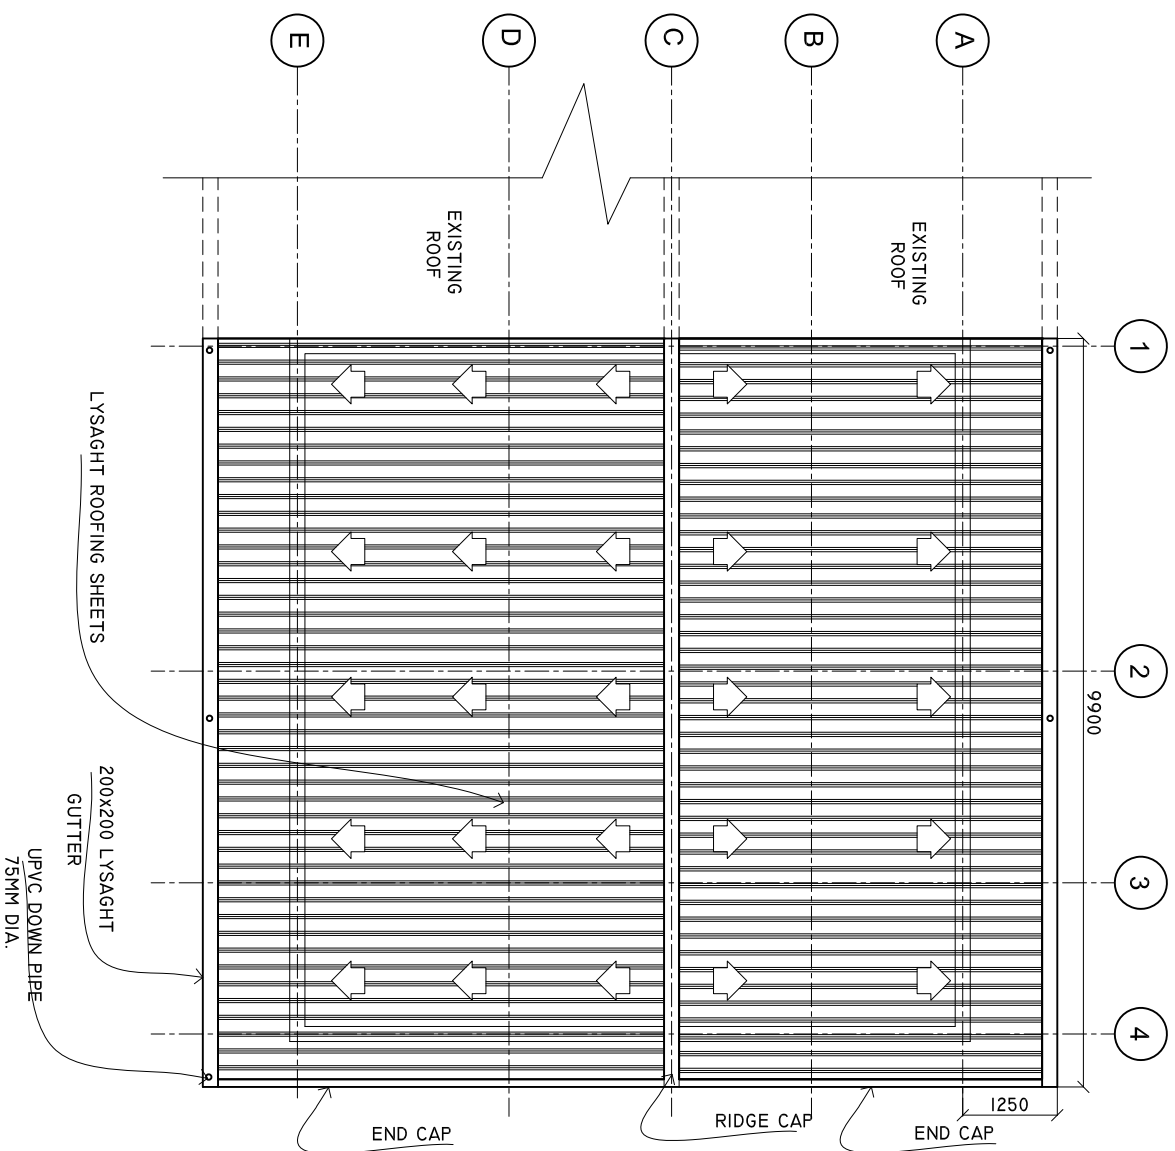

SHEET CONTENTS :

REVISION NOTES:

PROJECT:
EXTENSION OF ADH,
MANDHOO HEALTH
CENTER.

CLIENT:
MINISTRY OF HEALTH

LOCATION:
ADH , MANDHOO

CONTENTS: AS GIVEN

PROJECT MANAGER:

DESIGNER: ARIZ

CIV/STR. ENGINEER:

SURVEYED BY: -

DRAWN BY: ARIZ

CHECKED BY:

DATE : FEBRUARY 2021

SHEET NO. : /


PAPER SIZE: A3



ADMIN DIVISION
Ministry of Health
Roshanra Building
Sasana Majeed
Tel: 332 8887, Fax: 332 8889

ROOF FRAMING PLAN

SCALE: 1 : 100

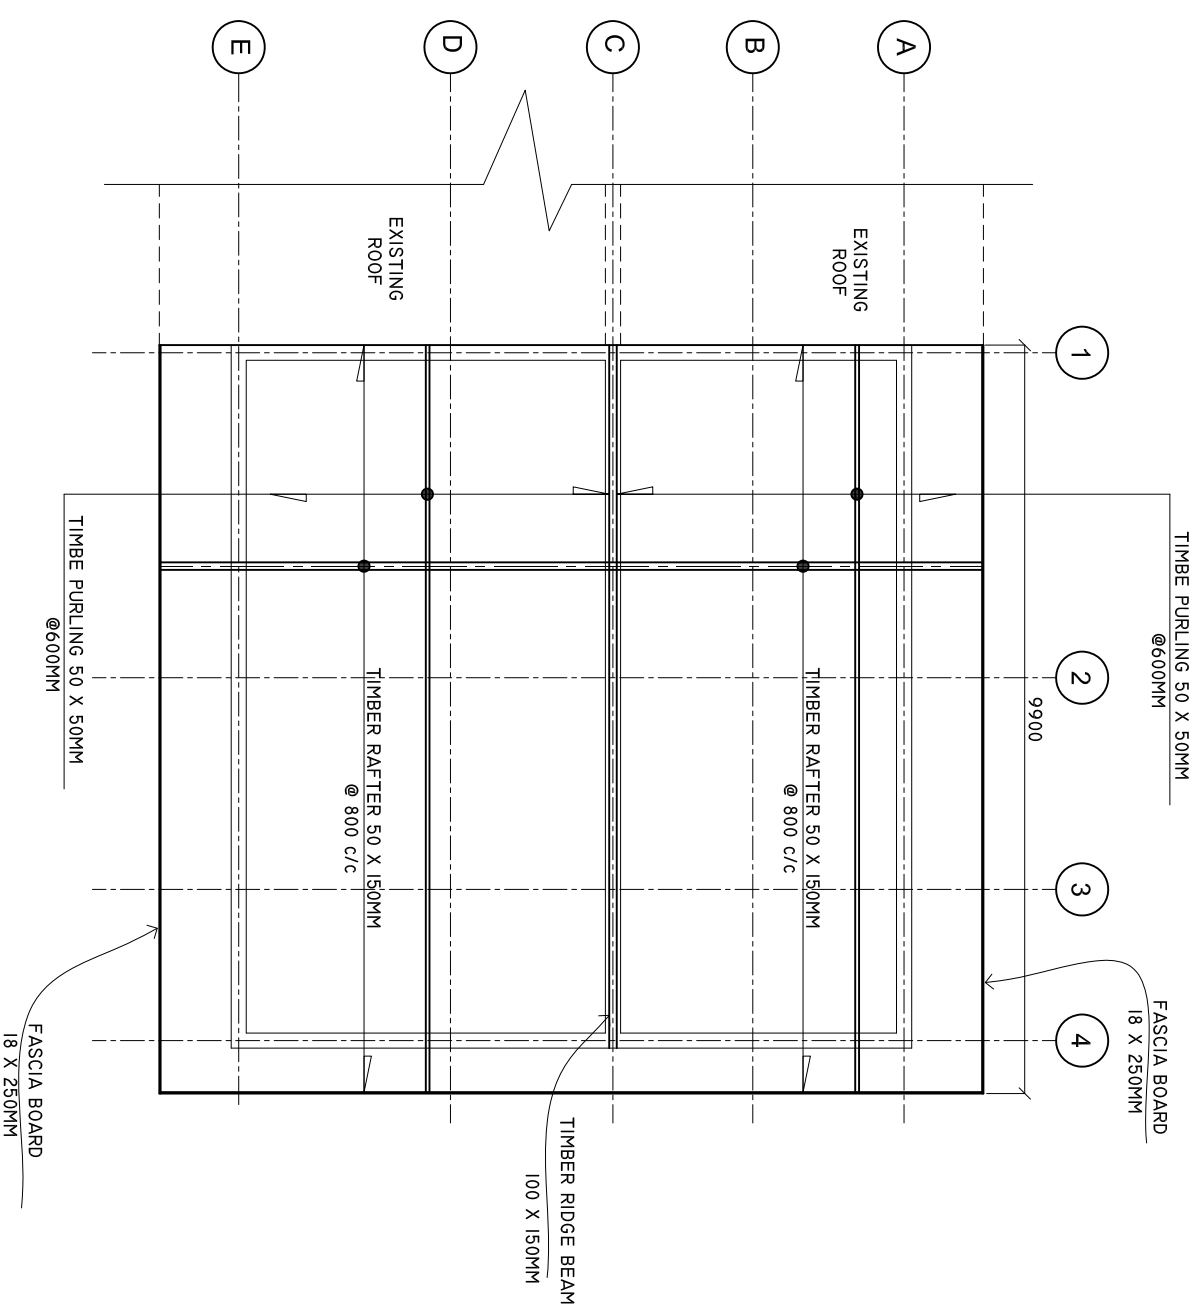

SHEET CONTENTS :

REVISION NOTES:

PROJECT:
EXTENSION OF ADH,
MANDHOO HEALTH
CENTER.

CLIENT:
MINISTRY OF HEALTH

LOCATION:
ADH, MANDHOO

CONTENTS: AS GIVEN

PROJECT MANAGER:

DESIGNER: ARIZ

CIV/STR. ENGINEER:

SURVEYED BY: -

DRAWN BY: ARIZ

CHECKED BY:

DATE : FEBRUARY 2021

SHEET NO. : /

PAPER SIZE: A3



DOORS AND WINDOWS SCHEDULE

Scale 1:50

SYMBOL	D1	D2	D3	W1	W2
ELEVATION					
LOCATION	GROUND FLOOR	GROUND FLOOR	GROUND FLOOR	GROUND FLOOR	GROUND FLOOR
QUANTITY	00 NOS	00 NOS	00 NOS	00 NOS	00 NOS
FRAME	ALUMINIUM FRAME DOOR	ALUMINIUM FRAME DOOR	ALUMINIUM FRAME DOOR	ALUMINIUM FRAME DOOR	ALUMINIUM FRAME DOOR
PANEL	ALUMINIUM 60-80 MICRON POWDER COATING	ALUMINIUM 60-80 MICRON POWDER COATING	ALUMINIUM 60-80 MICRON POWDER COATING	ALUMINIUM 60-80 MICRON POWDER COATING	ALUMINIUM 60-80 MICRON POWDER COATING
FINISH	ALUMINIUM IN 60-80 MICRON POWDER COATING	ALUMINIUM IN 60-80 MICRON POWDER COATING	ALUMINIUM IN 60-80 MICRON POWDER COATING	ALUMINIUM IN 60-80 MICRON POWDER COATING	ALUMINIUM IN 60-80 MICRON POWDER COATING
HINGE	STAINLESS STEEL	STAINLESS STEEL	STAINLESS STEEL	STAINLESS STEEL	STAINLESS STEEL
LOCK	STATE MAKE	STATE MAKE	STATE MAKE	STATE MAKE	STATE MAKE
NOTE	ALL MEASUREMENTS TO BE CHECKED ON SITE	ALL MEASUREMENTS TO BE CHECKED ON SITE	ALL MEASUREMENTS TO BE CHECKED ON SITE	ALL MEASUREMENTS TO BE CHECKED ON SITE	ALL MEASUREMENTS TO BE CHECKED ON SITE

SYMBOL	V1	V2	D4	D5
ELEVATION				
LOCATION	GROUND FLOOR	GROUND FLOOR	GROUND FLOOR	GROUND FLOOR
QUANTITY	00 NOS	00 NOS	00 NOS	00 NOS
FRAME	ALUMINIUM FRAME DOOR	ALUMINIUM FRAME DOOR	ALUMINIUM FRAME DOOR	SOLID TIMBER FRAME DOOR
PANEL	ALUMINIUM 60-80 MICRON POWDER COATING	ALUMINIUM 60-80 MICRON POWDER COATING	ALUMINIUM 60-80 MICRON POWDER COATING	TIMBER FRAME WITH 6MM PLYWOOD ON BOTH SIDE
FINISH	ALUMINIUM IN 60-80 MICRON POWDER COATING	ALUMINIUM IN 60-80 MICRON POWDER COATING	ALUMINIUM IN 60-80 MICRON POWDER COATING	PAINT FINISH
HINGE	STAINLESS STEEL	STAINLESS STEEL	STAINLESS STEEL	STAINLESS STEEL
LOCK	STATE MAKE	STATE MAKE	STATE MAKE	STATE MAKE
NOTE	ALL MEASUREMENTS TO BE CHECKED ON SITE	ALL MEASUREMENTS TO BE CHECKED ON SITE	ALL MEASUREMENTS TO BE CHECKED ON SITE	ALL MEASUREMENTS TO BE CHECKED ON SITE

NOTE:

PROVIDE RC LINTEL ABOVE ALL DOOR/WINDOW/VENTILATOR UNITS NOT FIXED TO BEAMS AND PROVIDE RC SILL BEAMS UNDER ALL WINDOW UNITS ALL TIMBER DOORS TO BE MADE OF TIMBER, PUTTY SMOOTHED AND FINISHED WITH ENAMEL PAINT AS SPECIFIED
 GL = 6MM TICK TINTED LAMINATED GLASS
 CL = 5 CLADDING SHEET, WHITE POWDER COATED ON BOTH SIDE.
 DOUBLE GLAZING

ALL THE ALUMINIUM PROFILE MUST BE MINIMUM 2MM THICK.

SHEET CONTENTS :

REVISION NOTES:

PROJECT: EXTENSION OF ADH, MANDHOO HEALTH CENTER.

CLIENT: MINISTRY OF HEALTH

LOCATION: ADH, MANDHOO

CONTENTS: AS GIVEN

PROJECT MANAGER:

DESIGNER: ARIZ

CIV/STR. ENGINEER:

SURVEYED BY: -

DRAWN BY: ARIZ

CHECKED BY:

DATE : FEBRUARY 2021


SHEET NO. : /

PAPER SIZE: A3

ADMIN DIVISION
 Ministry of Health
 Roslane Building
 Soan Marg
 Tel: 332 8887, Fax: 3328889


ELEVATION 'A'

SCALE: 1 : 100

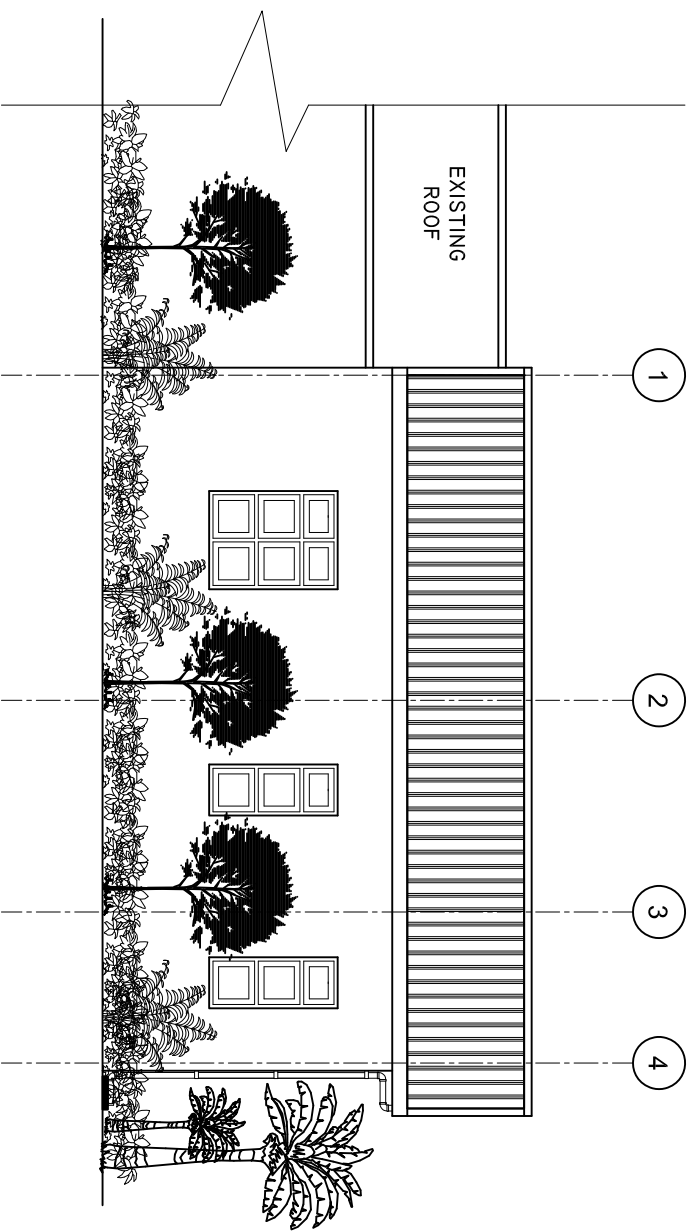

ELEVATION 'B'

SCALE: 1 : 100

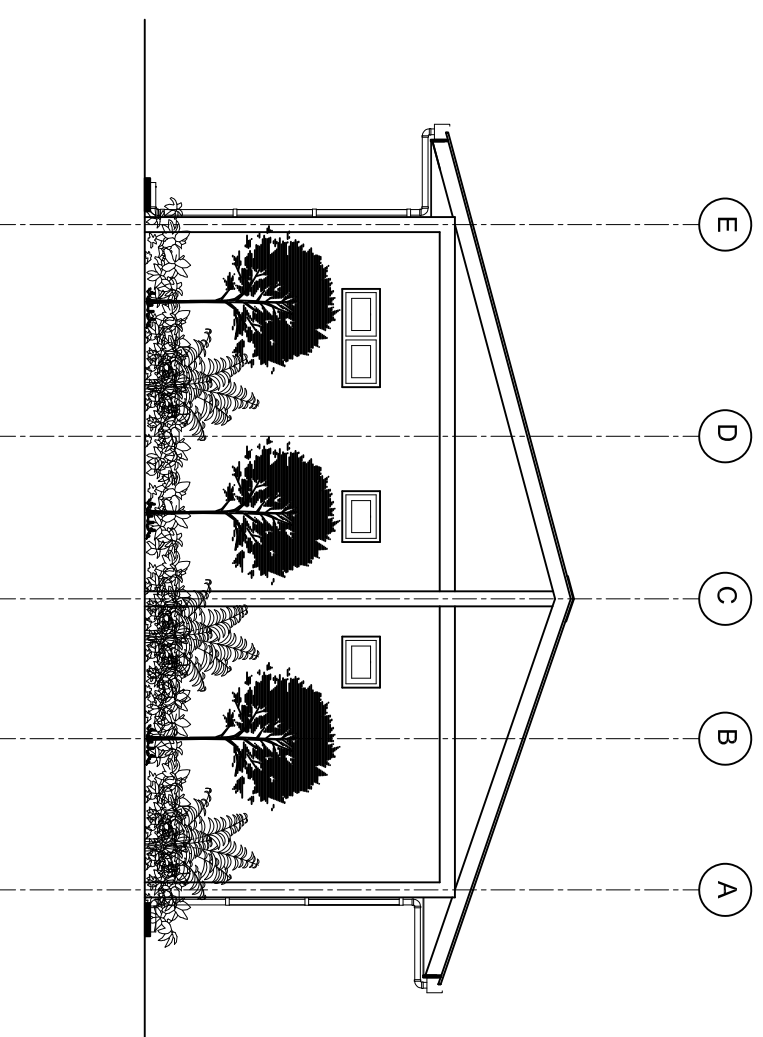

SHEET CONTENTS :

REVISION NOTES:

PROJECT:
EXTENSION OF ADH,
MANDHOO HEALTH
CENTER.

CLIENT:
MINISTRY OF HEALTH

LOCATION:
ADH , MANDHOO

CONTENTS: AS GIVEN

PROJECT MANAGER:

DESIGNER: ARIZ

CIV/STR. ENGINEER:

SURVEYED BY: -

DRAWN BY: ARIZ

CHECKED BY:

DATE : FEBRUARY 2021

SHEET NO. : /


PAPER SIZE: A3



ADMIN DIVISION
Ministry of Health
Roshanra Building
Sasun Nagar
Tel: 332 8887, Fax: 332 8889

ELECTRICAL LAYOUT

SCALE: 1 : 100

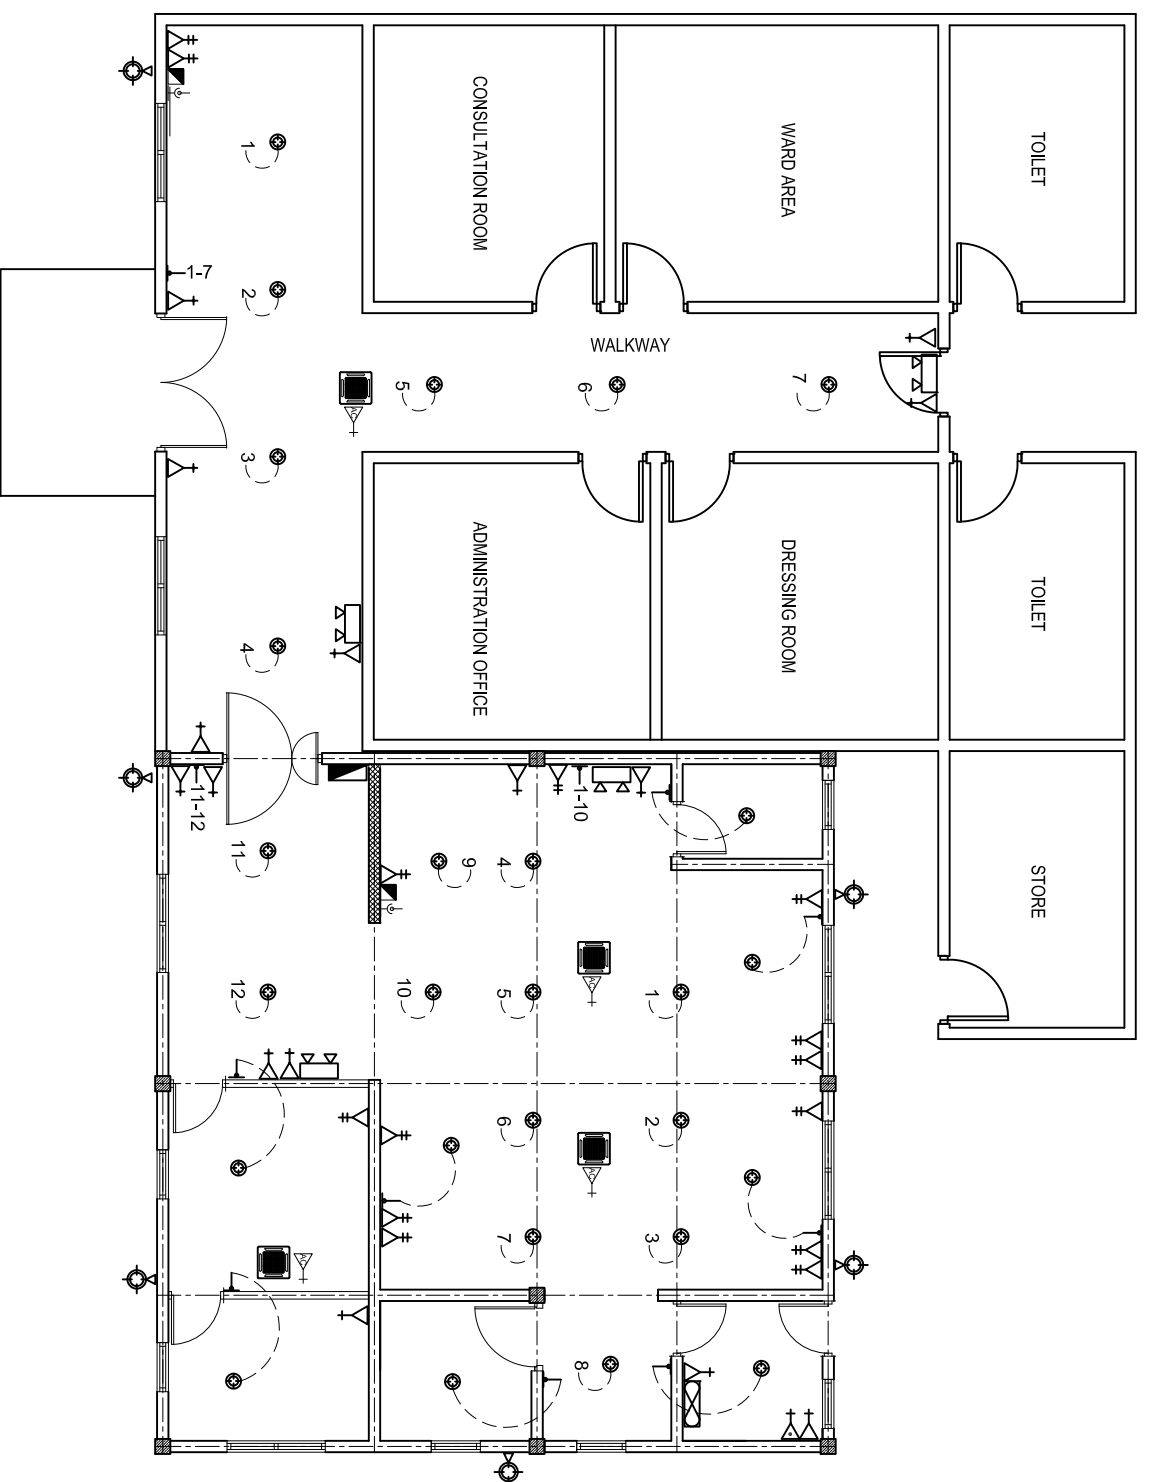

LEGEND

SYMBOL	DESCRIPTION
	1 x 13 AMP SOCKET OUTLET (200MM BELOW CEILING)
	WALL MOUNT FAN
	FAN REGULATOR
	5W BULB WITH COVERED
	CEILING FAN 1200MM DIA.
	AC INDOOR UNIT, CEILING CASSETTE TYPE
	OUTDOOR LIGHT
	AC OUT DOOR UNIT
	METER WITH OUT DOOR WATER PROOF BOX WITH TRANSPARENT FRONT DOOR

LEGEND

SYMBOL	DESCRIPTION
	LED BULB WITH 200MM DOWN LIGHT
	1 x 13 AMP SOCKET OUTLET (1600MM ABOVE FFL)
	2 x 13 AMP SOCKET OUTLET (600MM ABOVE FFL)
	1 x 15 AMP SOCKET OUTLET (600MM ABOVE FFL)
	1 x 15 AMP AC SOCKET OUTLET (300MM BLW. CEILING)
	TWO GANG SWITCH
	ONE WAY SWITCH
	EMERGENCY LIGHT
	DISTRIBUTION BOARD (WALL EMBEDDED)
	AC WALL MOUNT UNIT
	TELEPHONE SOCKET
	NETWORK SOCKET
	NETWORK SWITCH
	PABX

SHEET CONTENTS :

REVISION NOTES:

PROJECT:
EXTENSION OF ADH,
MANDHOO HEALTH
CENTER.

CLIENT:
MINISTRY OF HEALTH

LOCATION:
ADH, MANDHOO

CONTENTS: AS GIVEN

PROJECT MANAGER:

DESIGNER: ARIZ

CIV/STR. ENGINEER:

SURVEYED BY: -

DRAWN BY: ARIZ

CHECKED BY:

DATE : FEBRUARY 2021

SHEET NO. : /


PAPER SIZE: A3



ADMIN DIVISION
Ministry of Health
Roshanra Building
Sasun Nagar
Tel: 332 8887, Fax: 3328889

COLUMN LAYOUT

SCALE: 1 : 100

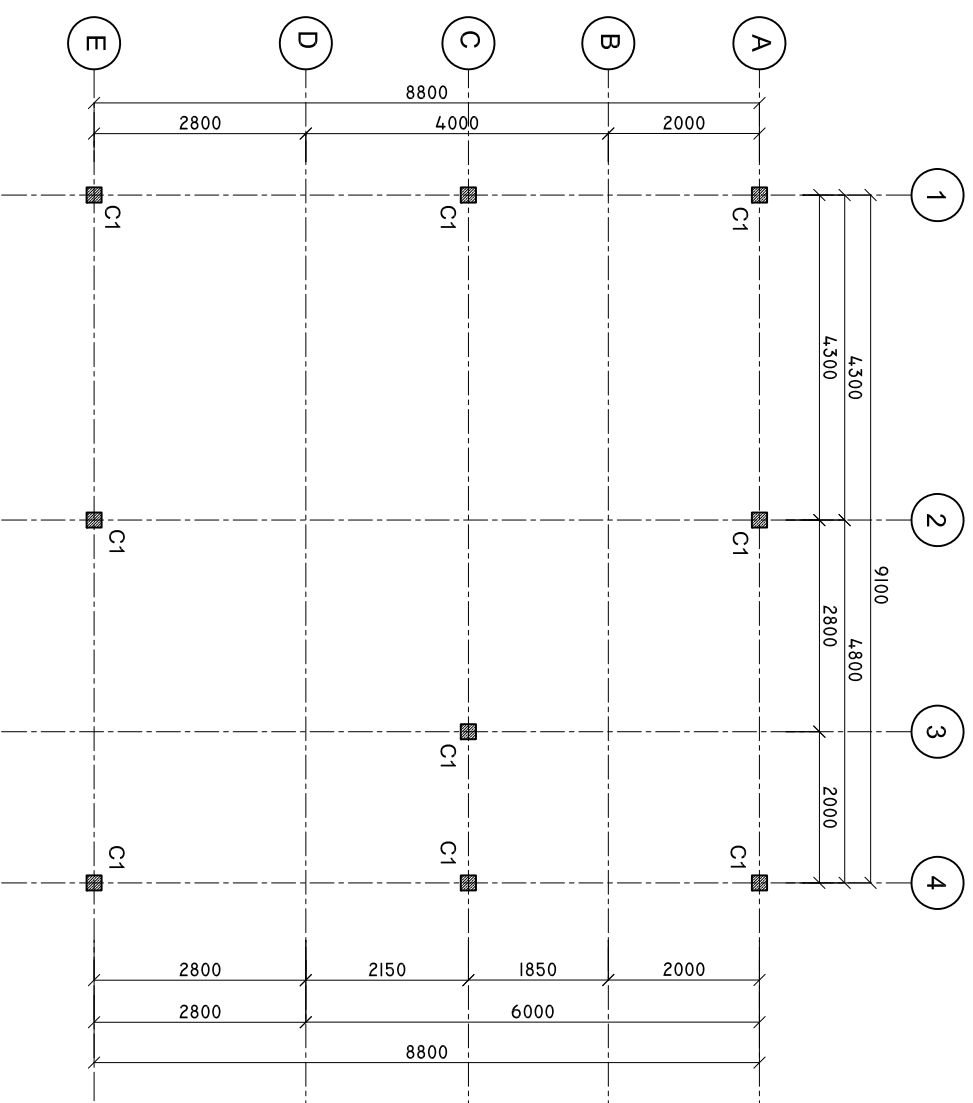

SHEET CONTENTS :

REVISION NOTES:

PROJECT:
EXTENSION OF ADH,
MANDHOO HEALTH
CENTER.

CLIENT:
MINISTRY OF HEALTH

LOCATION:
ADH, MANDHOO

CONTENTS: AS GIVEN

PROJECT MANAGER:

DESIGNER: ARIZ

CIV/STR. ENGINEER:

SURVEYED BY: -

DRAWN BY: ARIZ

CHECKED BY:

DATE : FEBRUARY 2021

SHEET NO. : /


PAPER SIZE: A3



ADMIN DIVISION
Ministry of Health
Roshanee Building
Sasana Maja
Tel: 332 8887, Fax: 332 8889

TIE BEAM PLAN

SCALE: 1 : 100

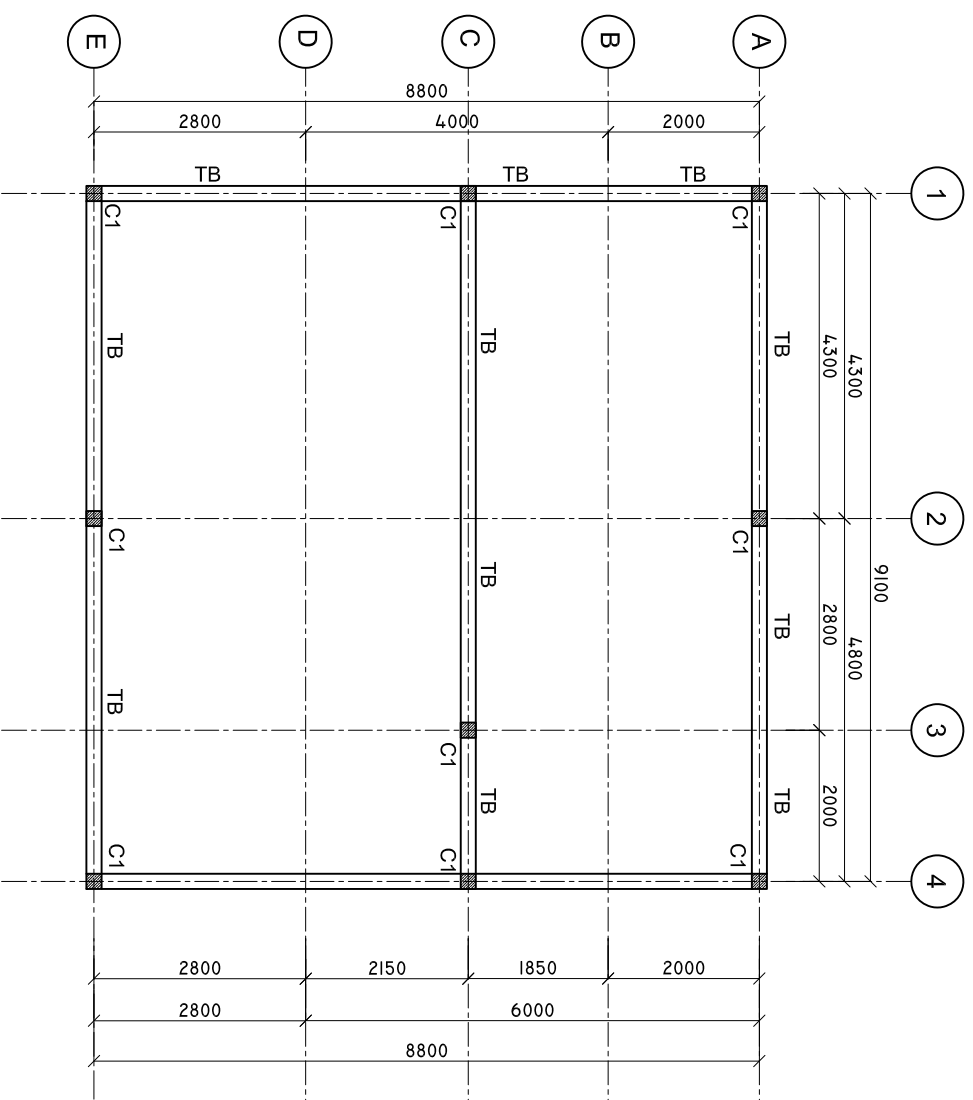

SHEET CONTENTS :

REVISION NOTES:

PROJECT:
EXTENSION OF ADH,
MANDHOO HEALTH
CENTER.

CLIENT:
MINISTRY OF HEALTH

LOCATION:
ADH , MANDHOO

CONTENTS: AS GIVEN

PROJECT MANAGER:

DESIGNER: ARIZ

CIV/STR. ENGINEER:

SURVEYED BY: -

DRAWN BY: ARIZ

CHECKED BY:

DATE : FEBRUARY 2021

SHEET NO. : /


PAPER SIZE: A3



ADMIN DIVISION
Ministry of Health
Roshanae Building
Soan Marg
Tel: 332 8887, Fax: 332 8889

ROOF BEAM PLAN

SCALE: 1 : 100

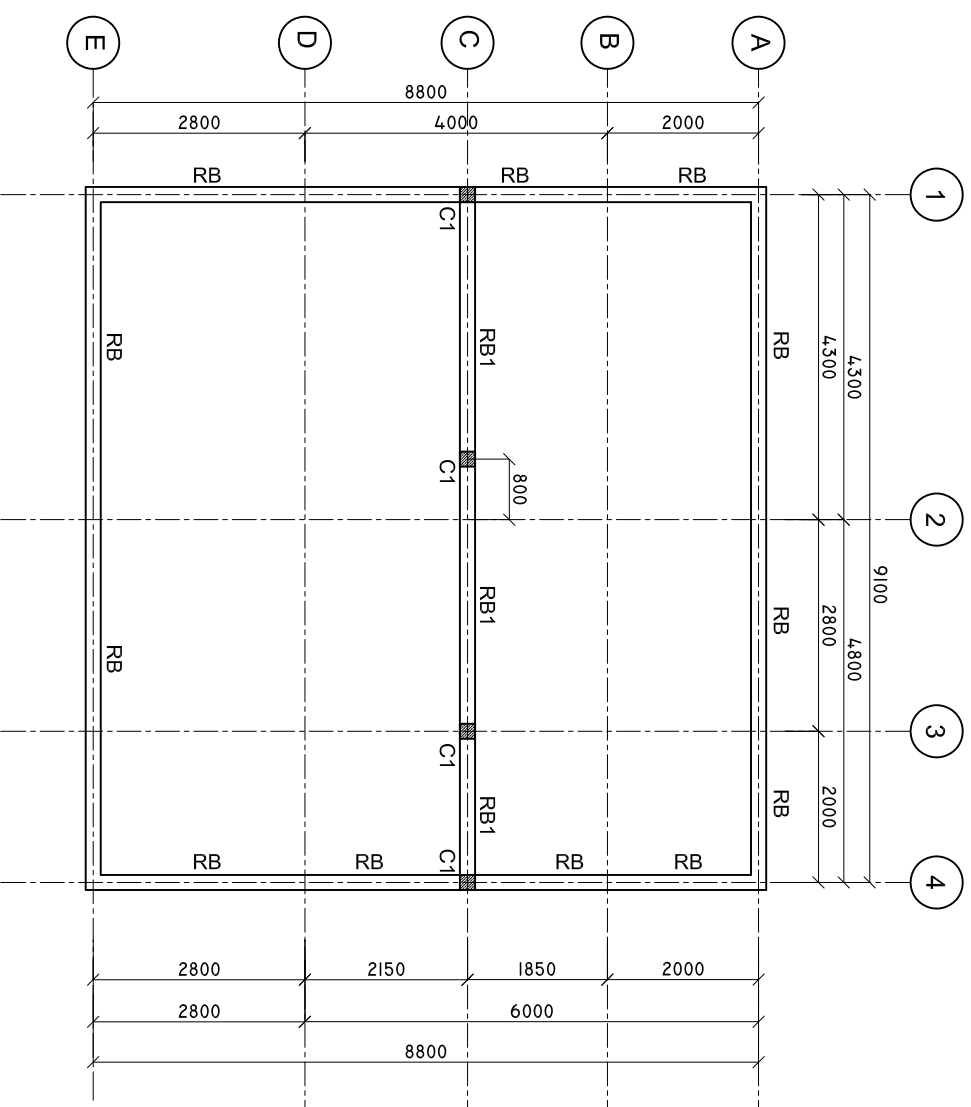

SHEET CONTENTS :

REVISION NOTES:

PROJECT:
EXTENSION OF ADH,
MANDHOO HEALTH
CENTER.

CLIENT:
MINISTRY OF HEALTH

LOCATION:
ADH, MANDHOO

CONTENTS: AS GIVEN

PROJECT MANAGER:

DESIGNER: ARIZ

CIV/STR. ENGINEER:

SURVEYED BY: -

DRAWN BY: ARIZ

CHECKED BY:

DATE : FEBRUARY 2021

 


SHEET NO. : /

PAPER SIZE: A3



DETAILS R/C




SCALE: 1 : 25

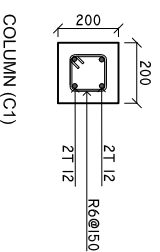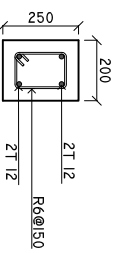

TIE BEAM (TB)

COLUMN (C1)

  SILL BEAM

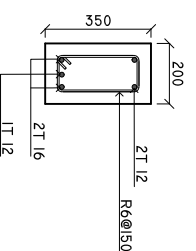

ROOF BEAM (RB)

ROOF BEAM (RB1)

LINTEL BEAM

MINIMUM 50MM COVER BELOW GROUND LEVEL	ALL BAR BENDING & OVERLAPS AS PER ACTUAL BS STANDARD.
MINIMUM 30MM COVER ABOVE GROUND LEVEL	

NOTE:
LINTEL BEAMS TO BE LAID ABOVE AND BELOW ALL WINDOWS AND ALL DOORS.

SHEET CONTENTS :

REVISION NOTES:

PROJECT:
EXTENSION OF ADH,
MANDHOO HEALTH
CENTER.

CLIENT:

MINISTRY OF HEALTH

LOCATION:

ADH , MANDHOO

CONTENTS: AS GIVEN

PROJECT MANAGER:

DESIGNER: ARIZ

CIV/STR. ENGINEER:

SURVEYED BY: -

DRAWN BY: ARIZ

CHECKED BY:

DATE : FEBRUARY 2021

SHEET NO. : /


PAPER SIZE: A3



ADMIN DIVISION
Ministry of Health
Roshanee Building
Sasana Marg
Tel: 332 8887, Fax: 3328889

CROSS SECTION X-X

SCALE: 1 : 50

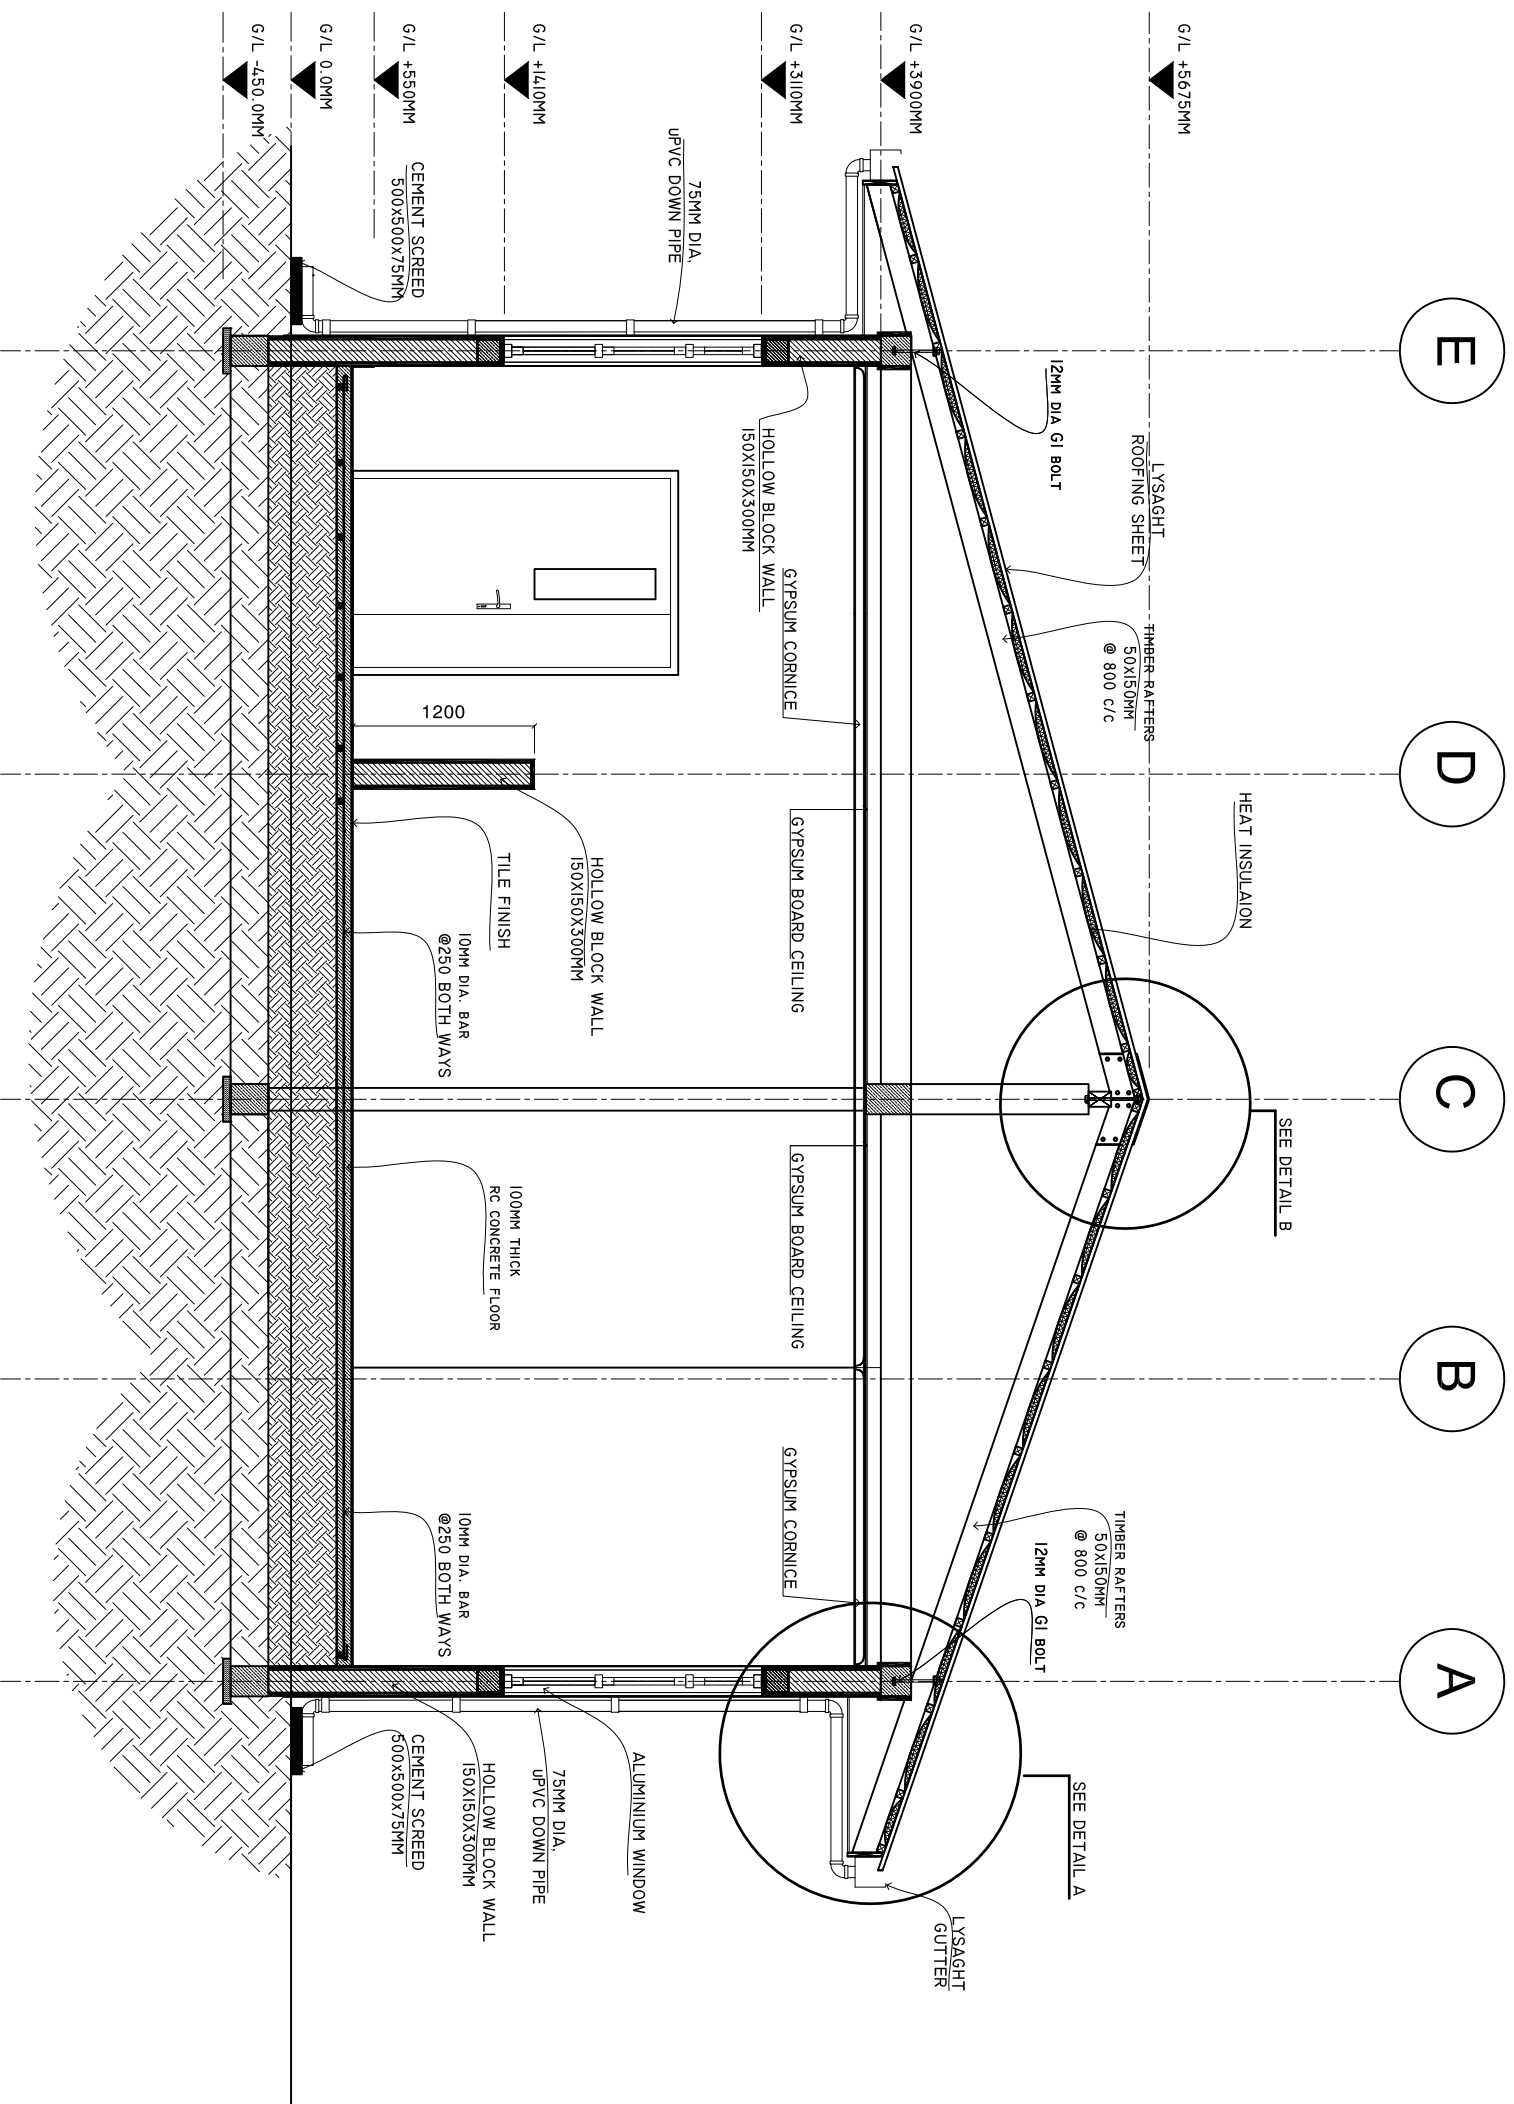

SHEET CONTENTS :

REVISION NOTES:

PROJECT:
EXTENSION OF ADH,
MANDHOO HEALTH
CENTER.

CLIENT:
MINISTRY OF HEALTH

LOCATION:
ADH, MANDHOO

CONTENTS: AS GIVEN

PROJECT MANAGER:

DESIGNER: ARIZ

CIV/STR. ENGINEER:

SURVEYED BY: -

DRAWN BY: ARIZ

CHECKED BY:

DATE : FEBRUARY 2021


SHEET NO. : /

PAPER SIZE: A3



DETAIL A

SCALE: 1 : 10

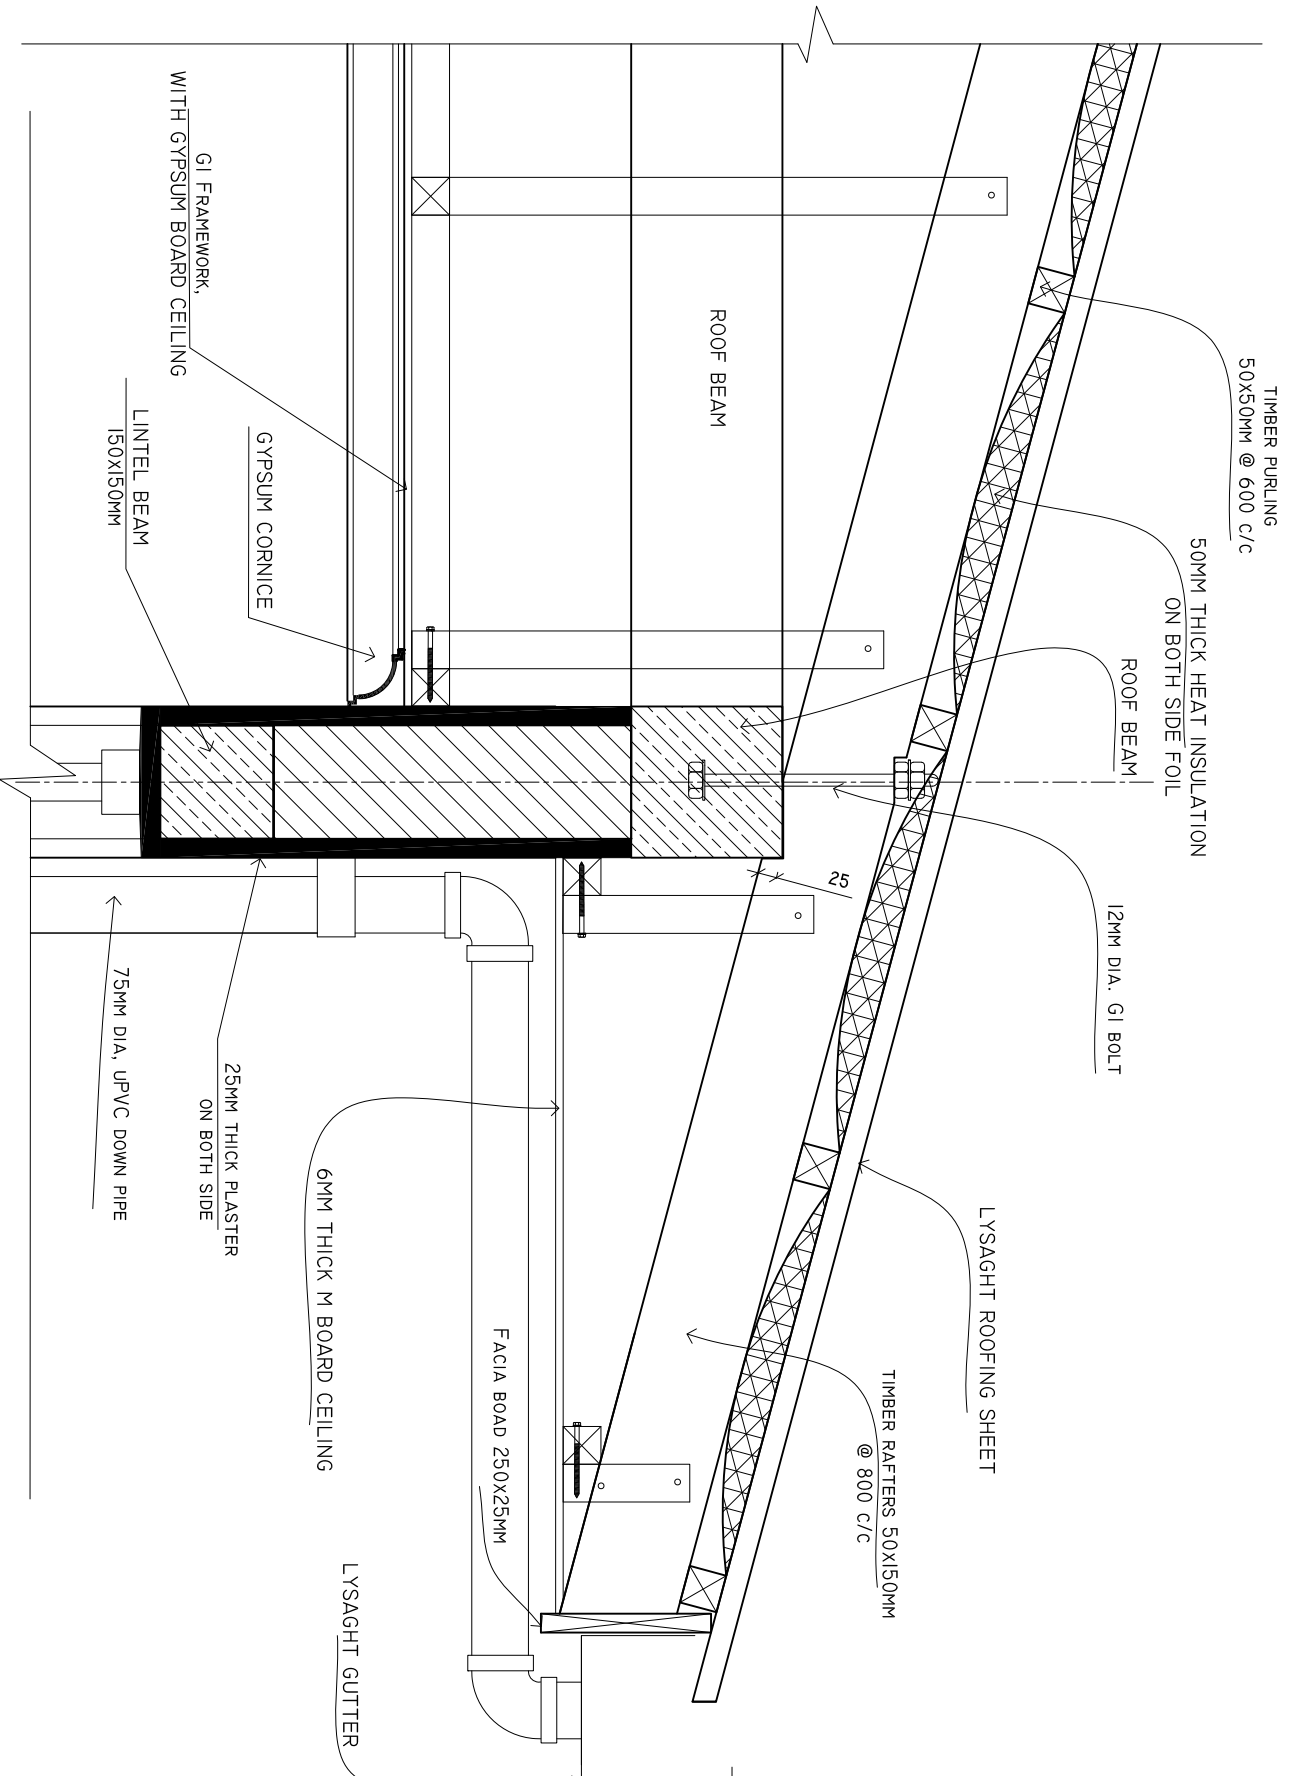

SHEET CONTENTS :

REVISION NOTES:

PROJECT:
EXTENSION OF ADH,
MANDHOO HEALTH
CENTER.

CLIENT:

MINISTRY OF HEALTH

LOCATION:

ADH, MANDHOO

CONTENTS: AS GIVEN

PROJECT MANAGER:

DESIGNER: ARIZ

CIV/STR. ENGINEER:

SURVEYED BY: -

DRAWN BY: ARIZ

CHECKED BY:

DATE : FEBRUARY 2021


SHEET NO. : /

PAPER SIZE: A3



ADMIN DIVISION
Ministry of Health
Roshanra Building
Soan Mandi
Tel: 332 8887, Fax: 332 8889

DETAIL B
SCALE: 1 : 10

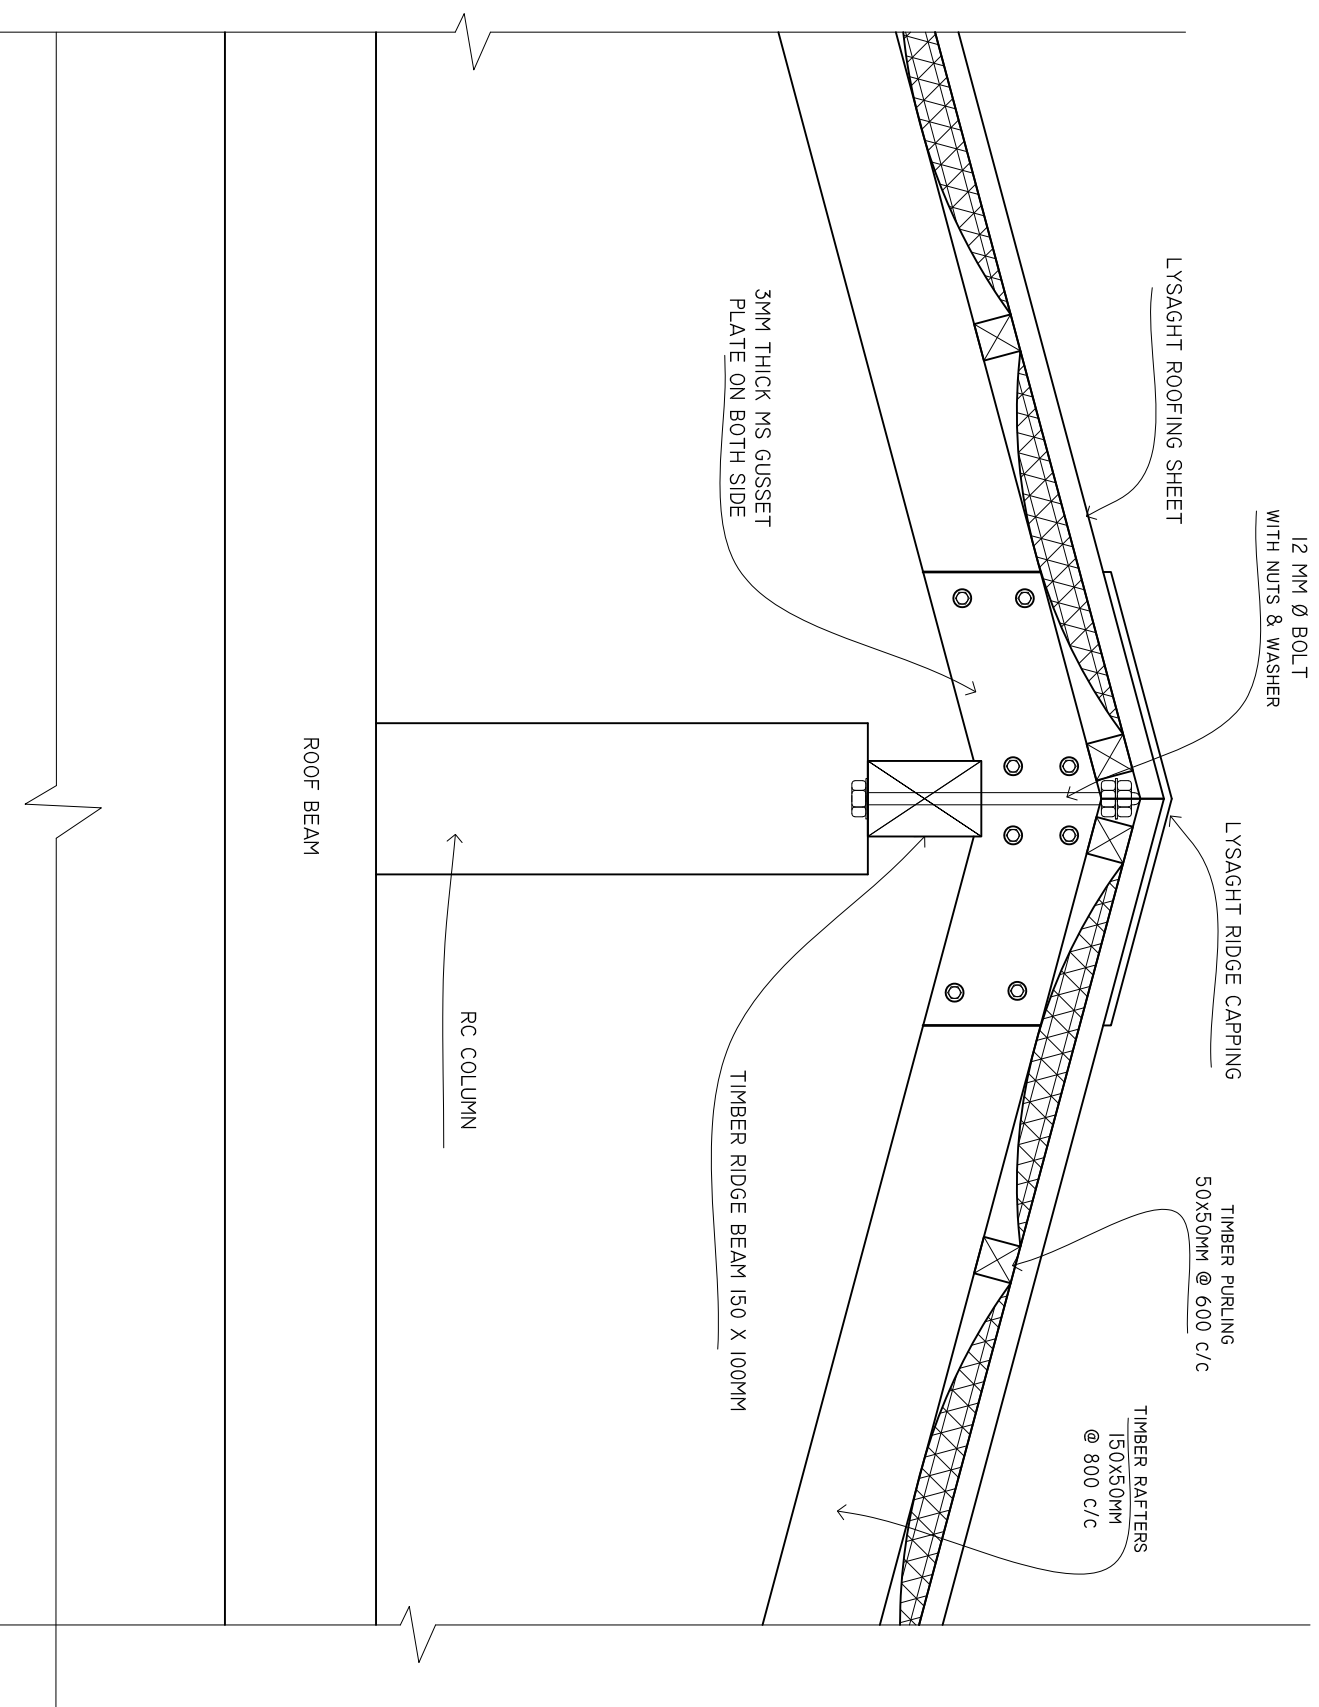

SHEET CONTENTS :

REVISION NOTES:

PROJECT:
EXTENSION OF ADH,
MANDHOO HEALTH
CENTER.

CLIENT:
MINISTRY OF HEALTH

LOCATION:
ADH, MANDHOO

CONTENTS: AS GIVEN

PROJECT MANAGER:

DESIGNER: ARIZ

CIV/STR. ENGINEER:

SURVEYED BY: -

DRAWN BY: ARIZ

CHECKED BY:


DATE : FEBRUARY 2021

SHEET NO. : /

PAPER SIZE: A3




NURSE STATION SIN CUPBOARD

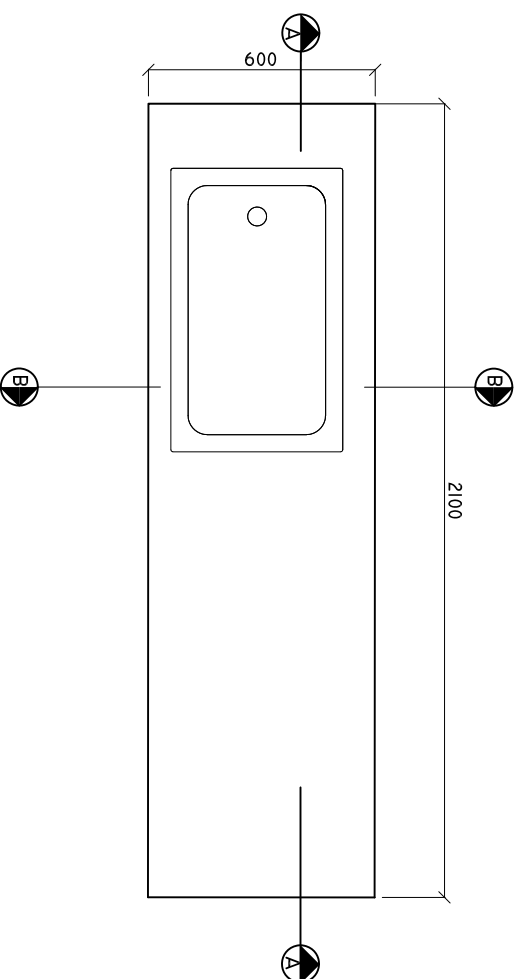


NOTE: PLEASE CHECK ALL MEASUREMENTS ON SITE BEFORE CARRYING OUT WORK

SINK CUPBOARD SECTION A-A SCALE: 1 : 20

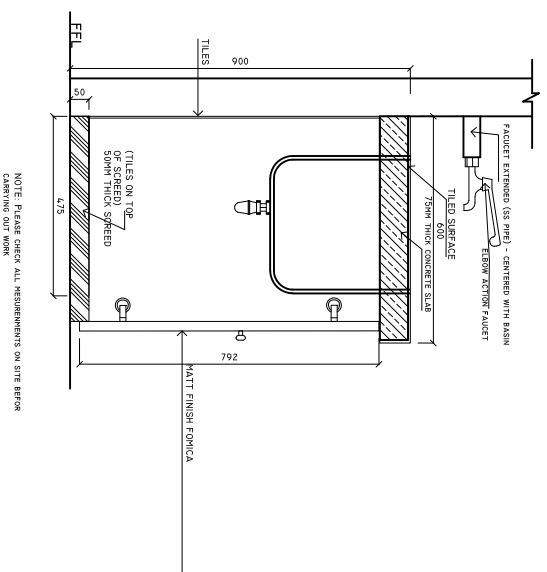


SINK CUPBOARD DETAIL B-B

SCALE: 1 : 20

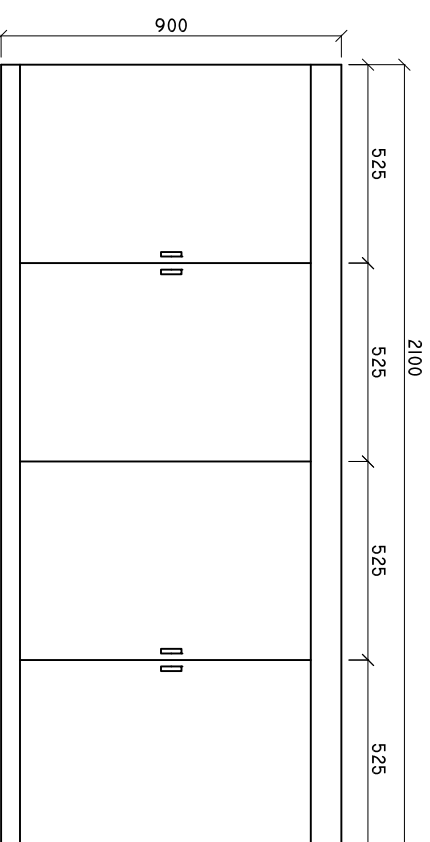

NOTE: PLEASE CHECK ALL MEASUREMENTS ON SITE BEFORE CARRYING OUT WORK

SINK CUPBOARD ELEVATION SCALE: 1 : 20

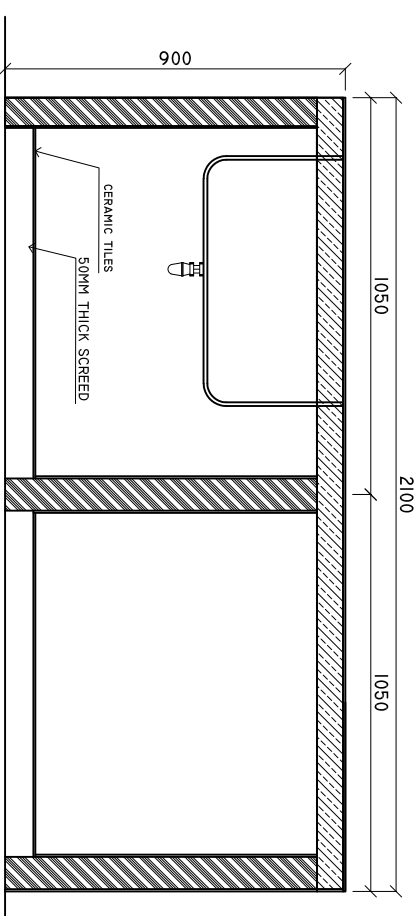

SINK CUPBOARD DETAIL A-A

SCALE: 1 : 20

SHEET CONTENTS :

REVISION NOTES:

PROJECT:
EXTENSION OF ADH,
MANDHOO HEALTH
CENTER.

CLIENT:
MINISTRY OF HEALTH

LOCATION:
ADH , MANDHOO

CONTENTS: AS GIVEN

PROJECT MANAGER:

DESIGNER: ARIZ

CIV/STR. ENGINEER:

SURVEYED BY: -

DRAWN BY: ARIZ

CHECKED BY:

DATE : FEBRUARY 2021

SHEET NO. : /


PAPER SIZE: A3




ADMIN DIVISION
Ministry of Health
Roshanara Building
Sasana Majeed
Tel: 332 8887, Fax: 3328889

REGISTRATION COUNTER PLAN


SCALE: 1 : 10

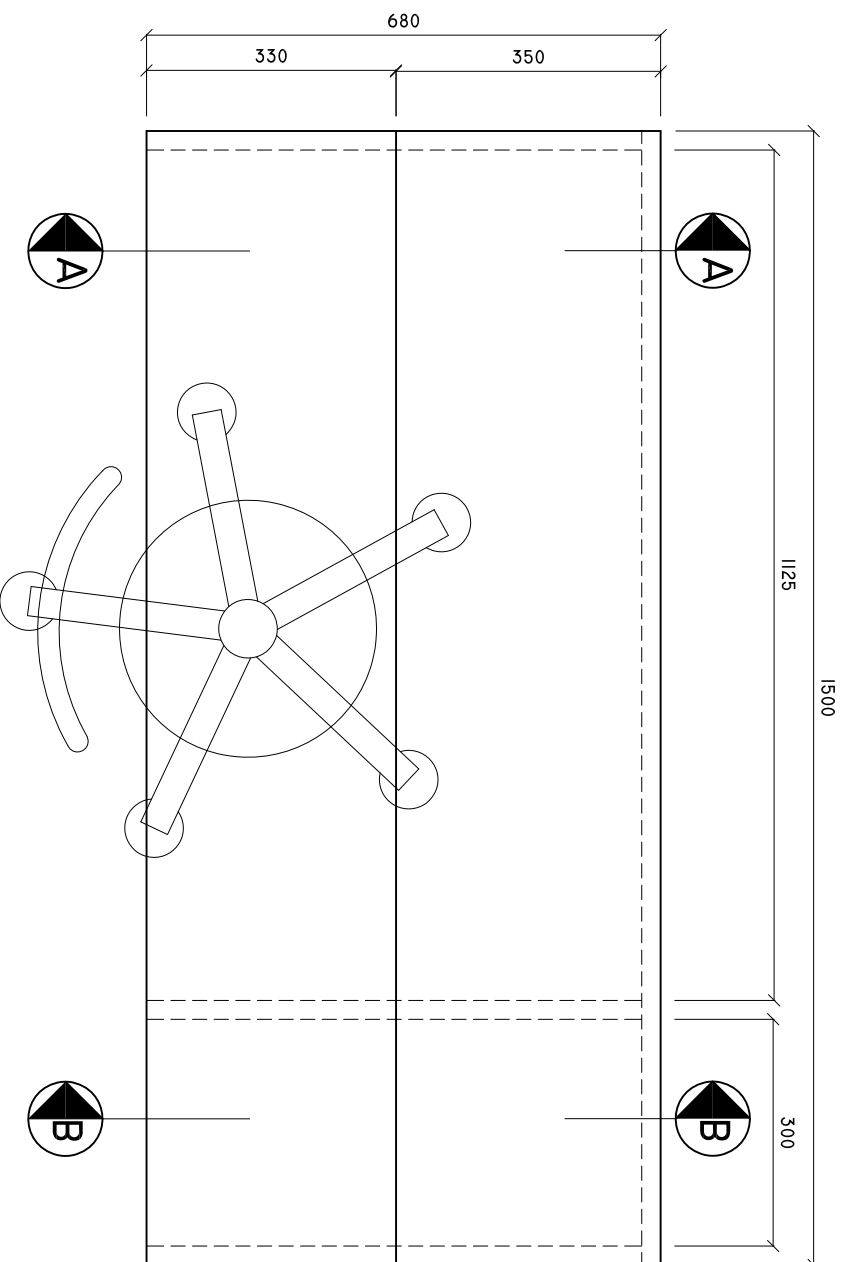

REGISTRATION COUNTER FRONT VIEW
SCALE: 1 : 10

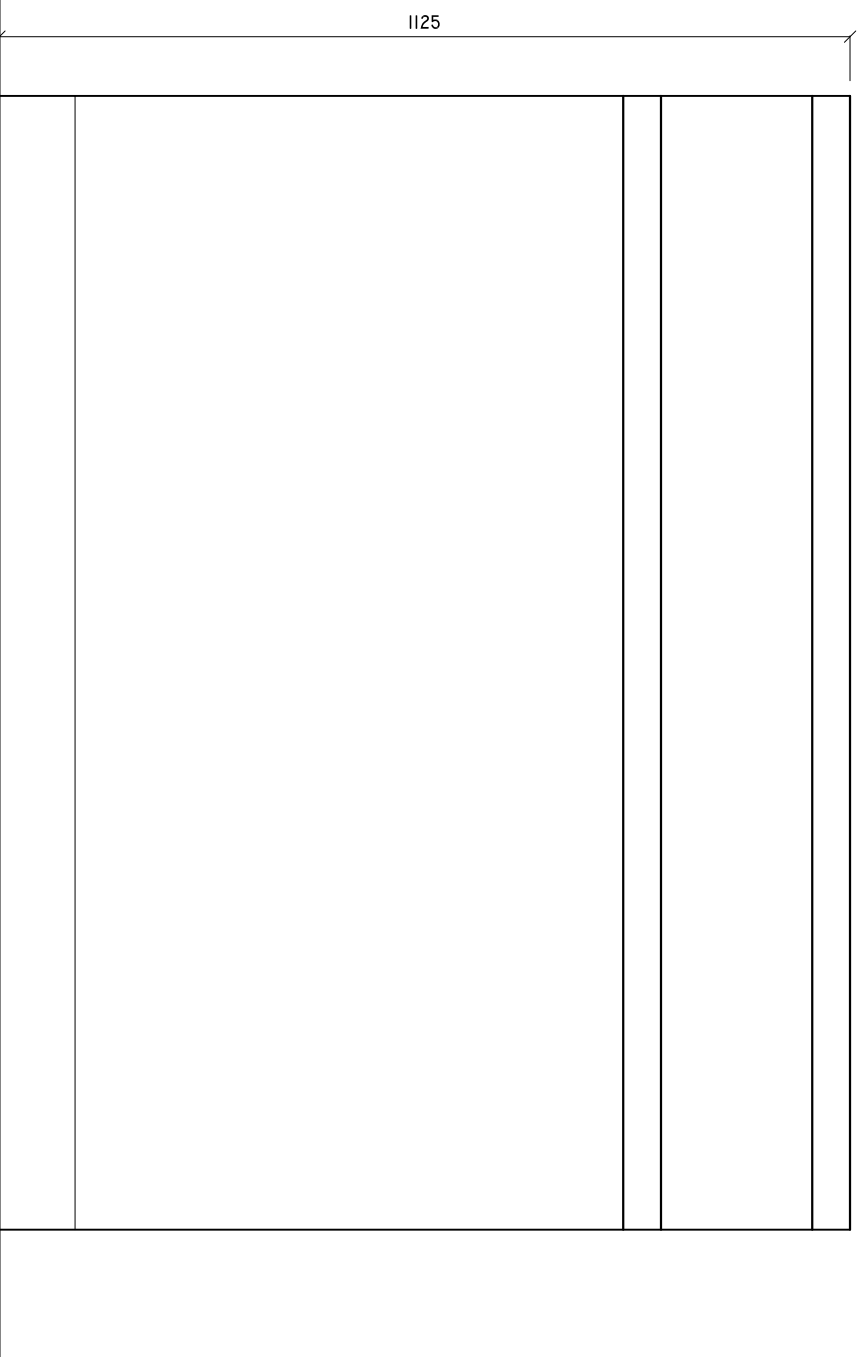

REGISTRATION COUNTER SIDE VIEW
SCALE: 1 : 10

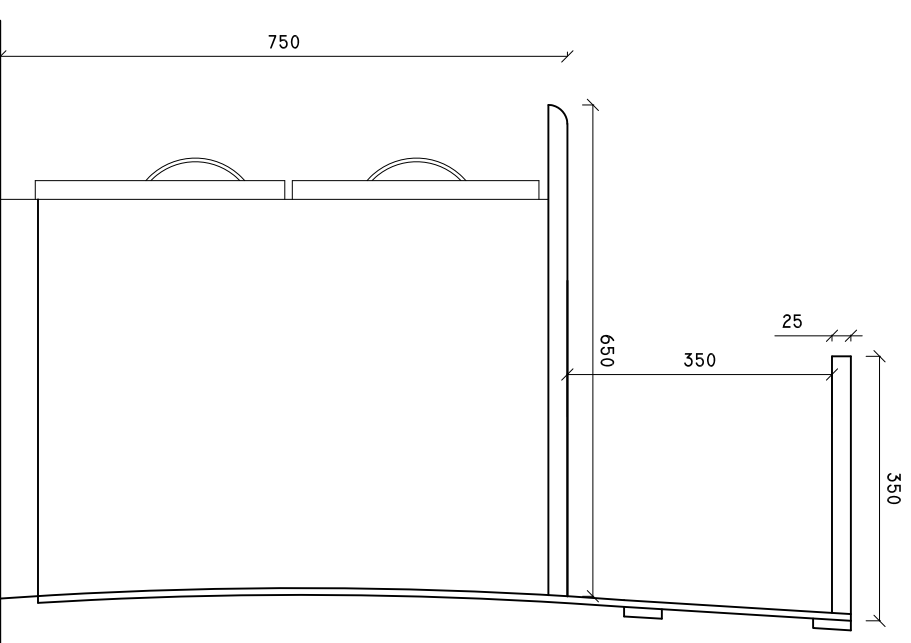

SHEET CONTENTS :

REVISION NOTES:

PROJECT:
EXTENSION OF ADH,
MANDHOO HEALTH
CENTER.

CLIENT:

MINISTRY OF HEALTH

LOCATION:

ADH, MANDHOO

CONTENTS: AS GIVEN

PROJECT MANAGER:

DESIGNER: ARIZ

CIV/STR. ENGINEER:

SURVEYED BY: -

DRAWN BY: ARIZ

CHECKED BY:

DATE : FEBRUARY 2021


SHEET NO. : /

PAPER SIZE: A3




REGISTRATION COUNTER SECTION A-A

SCALE: 1 : 10

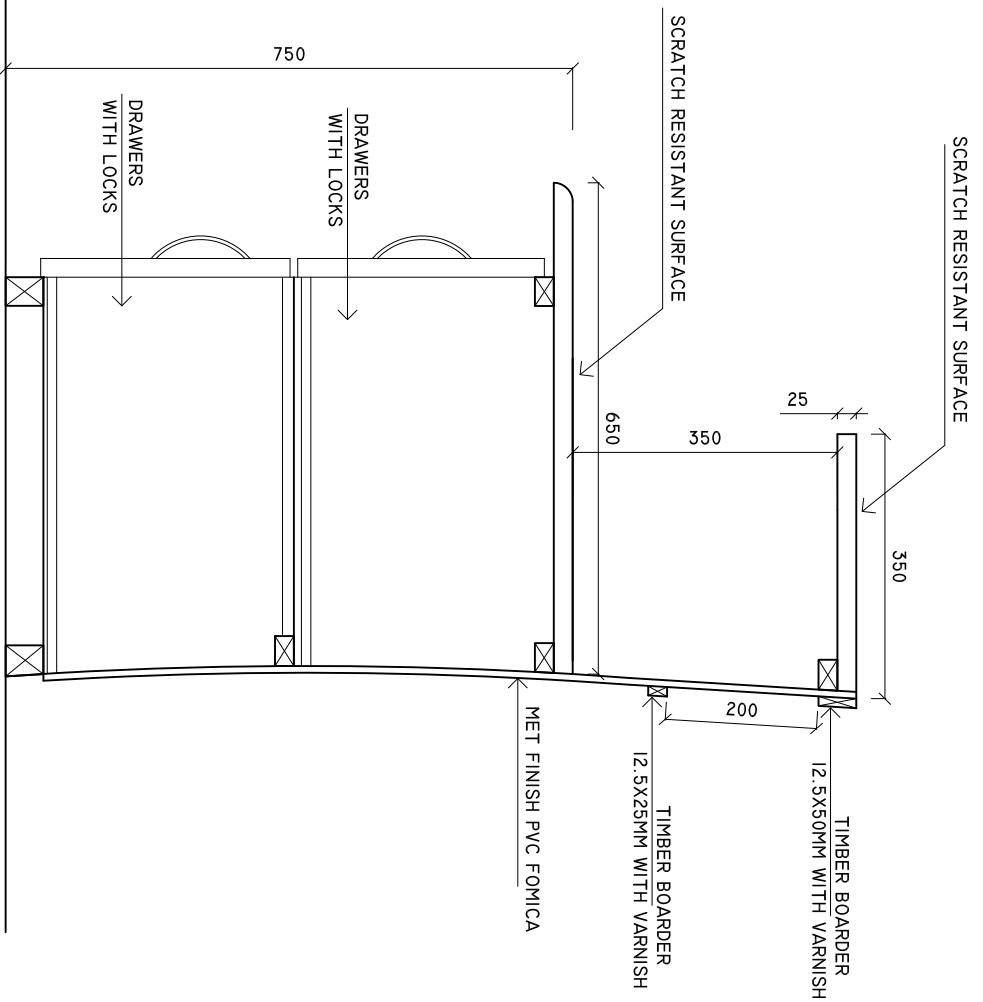

REGISTRATION COUNTER SECTION B-B

SCALE: 1 : 10

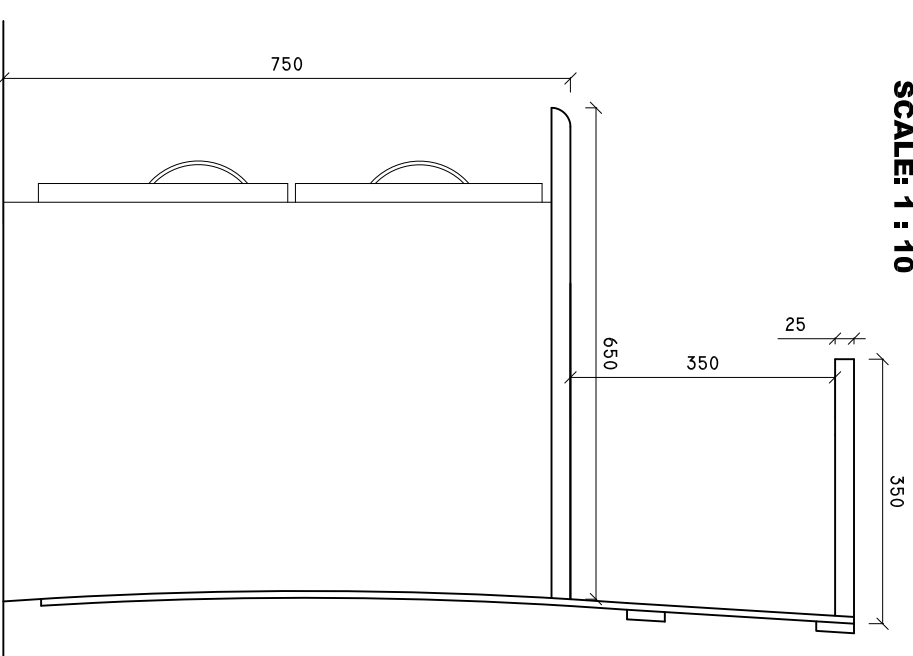

SHEET CONTENTS :

REVISION NOTES:

PROJECT:
EXTENSION OF ADH,
MANDHOO HEALTH
CENTER.

CLIENT:

MINISTRY OF HEALTH

LOCATION:

ADH, MANDHOO

CONTENTS: AS GIVEN

PROJECT MANAGER:

DESIGNER: ARIZ

CIV/STR. ENGINEER:

SURVEYED BY: -

DRAWN BY: ARIZ

CHECKED BY:

DATE : FEBRUARY 2021

SHEET NO. : /


PAPER SIZE: A3



ADMIN DIVISION
Ministry of Health
Roshanore Building
Soan Marg
Tel: 332 8887, Fax: 3328889


NURSE STATION COUNTER FRONT VIEW

SCALE: 1 : 10

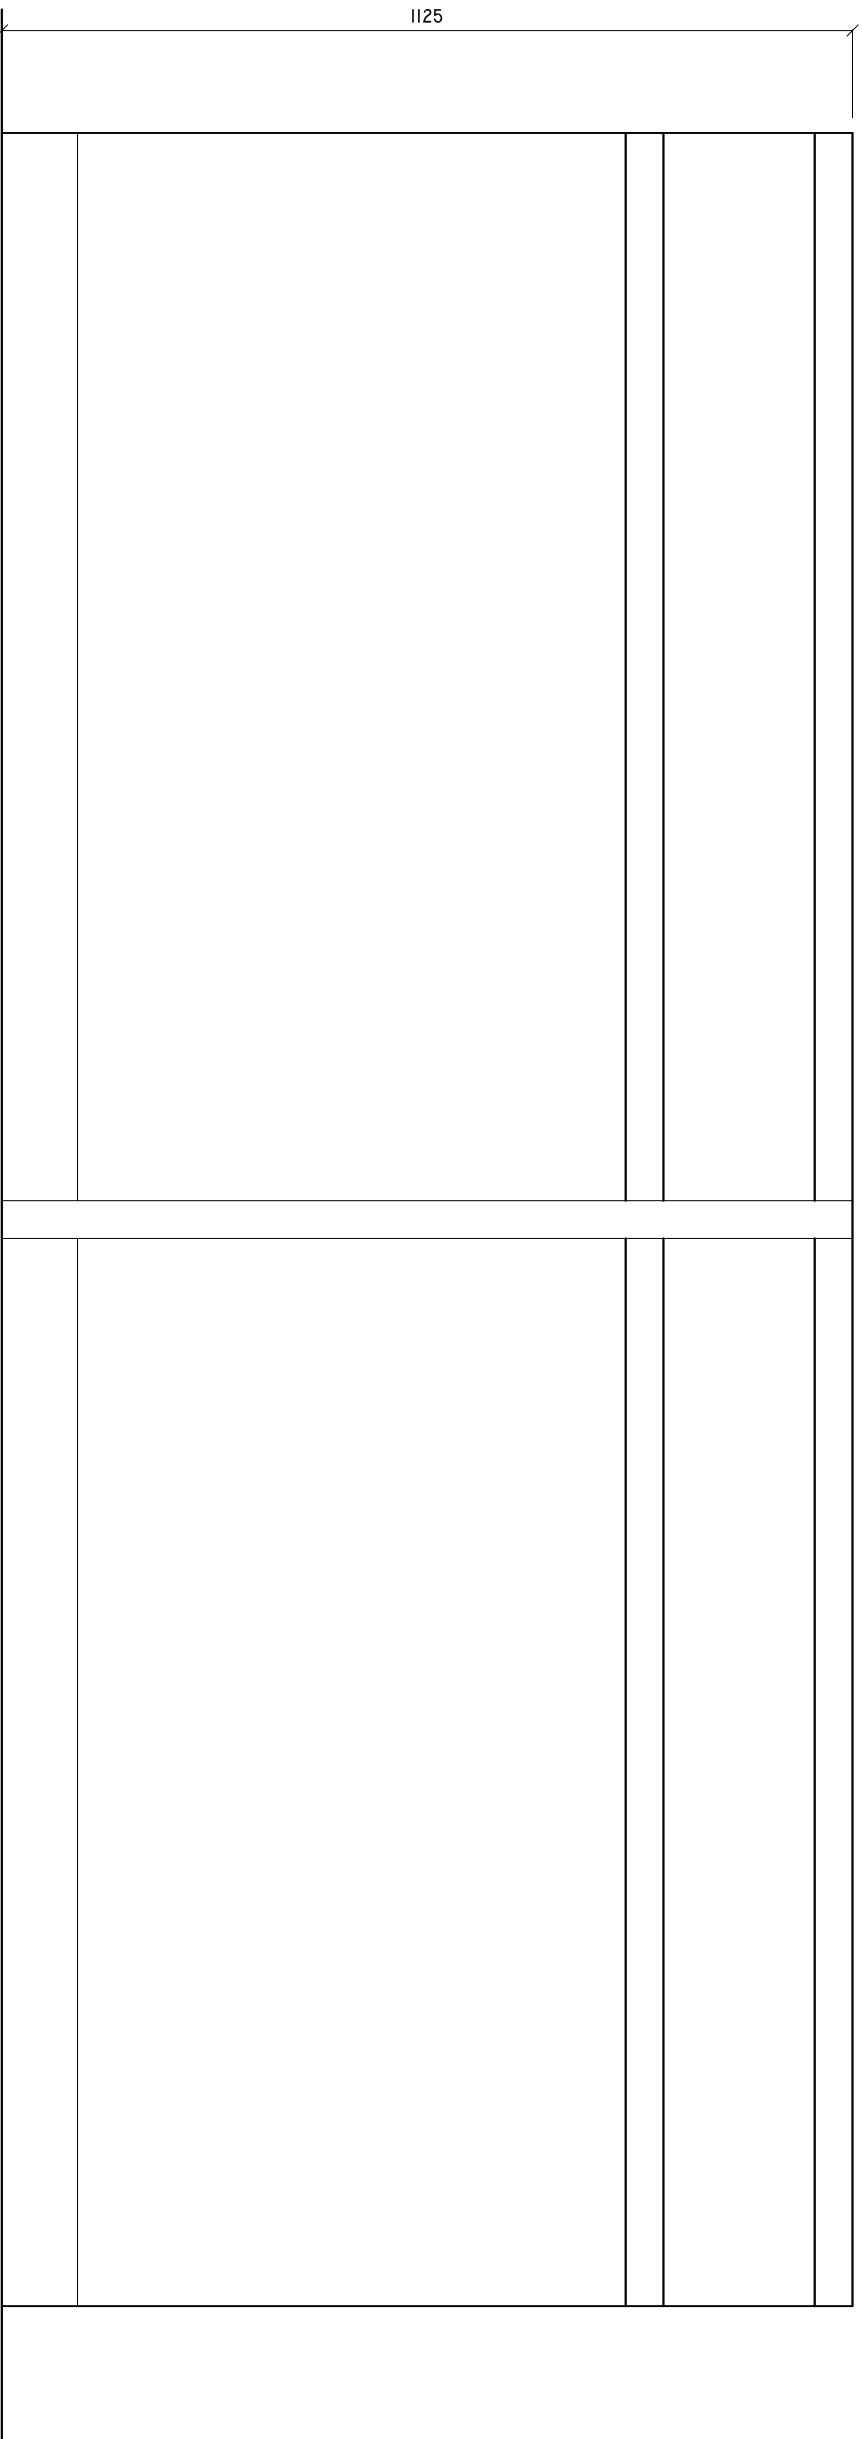

REGISTRATION COUNTER PLAN

SCALE: 1 : 10

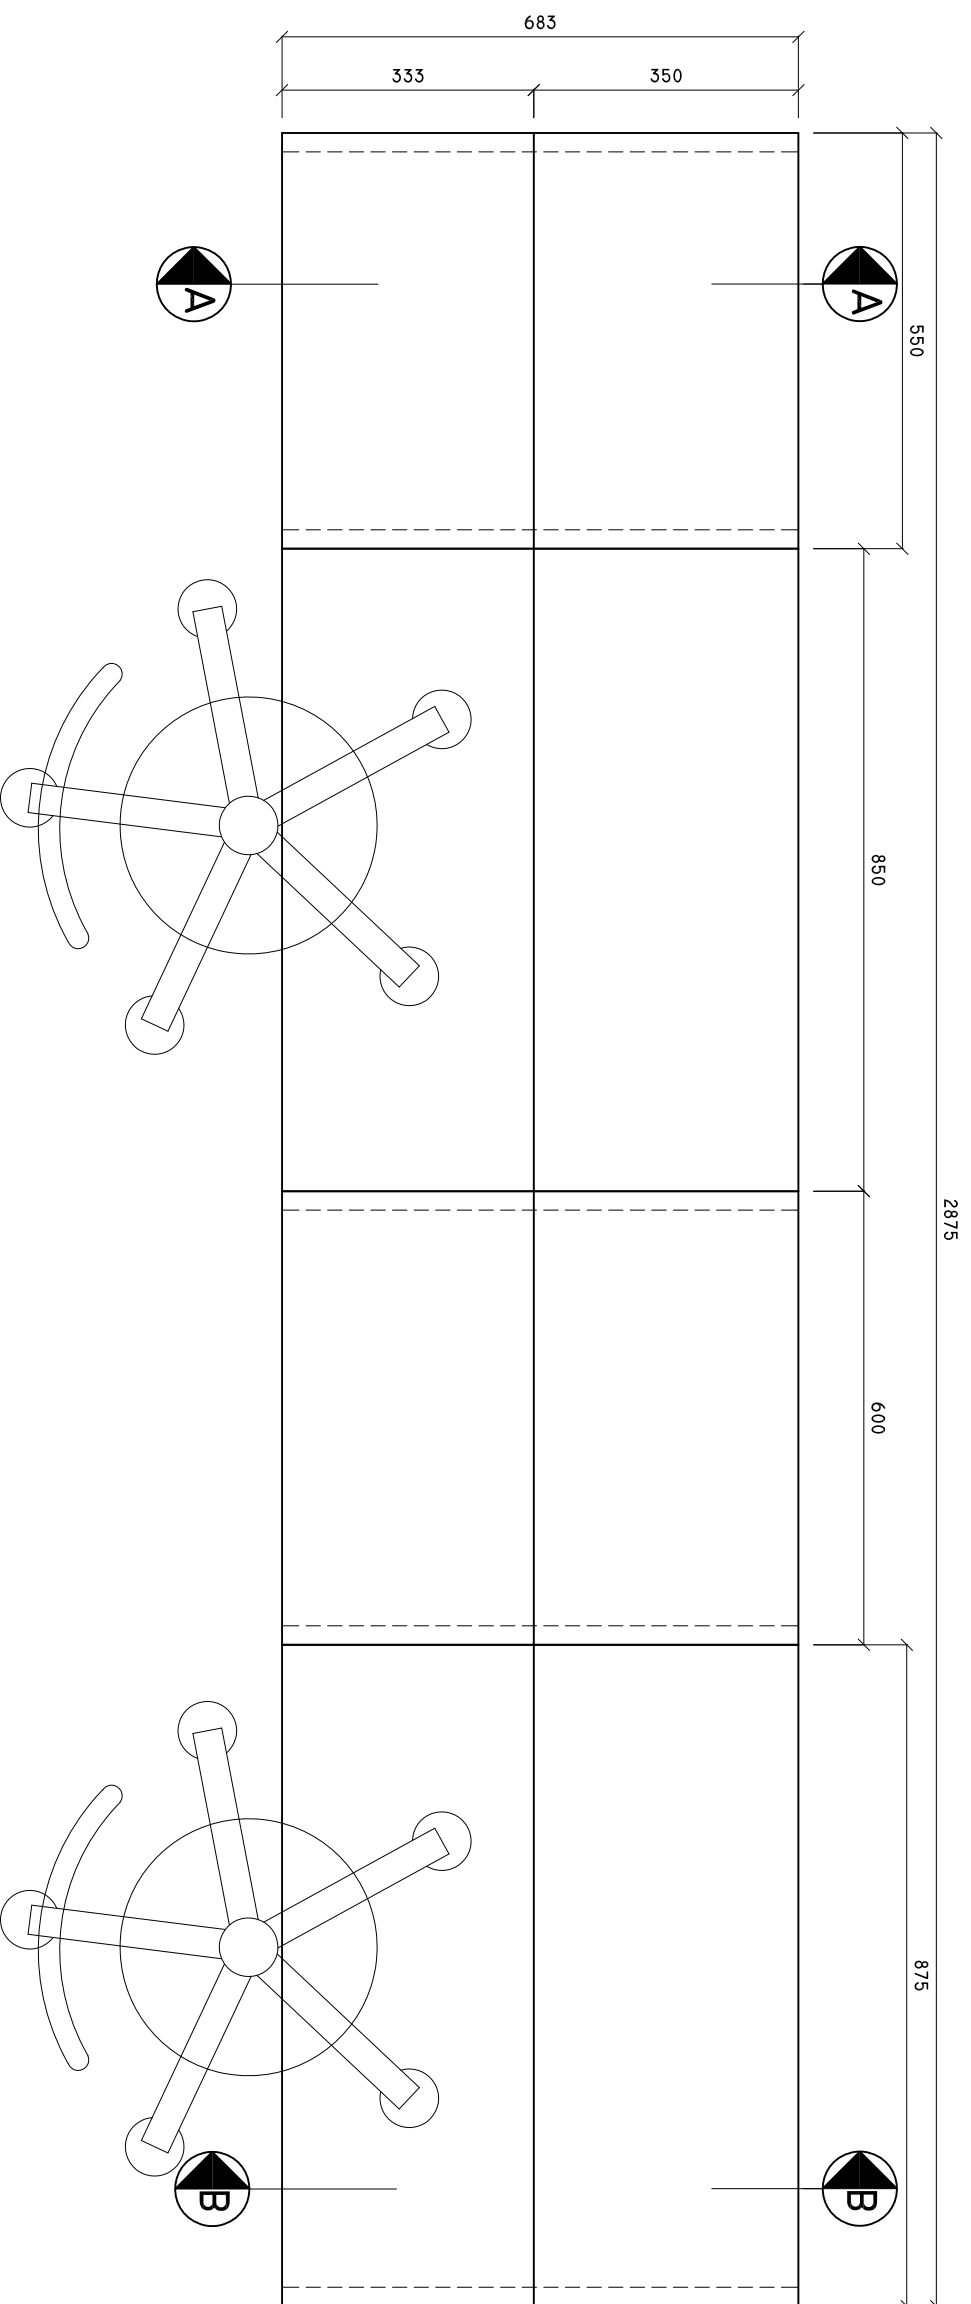

SHEET CONTENTS :

REVISION NOTES:

PROJECT:
EXTENSION OF ADH,
MANDHOO HEALTH
CENTER.

CLIENT:
MINISTRY OF HEALTH

LOCATION:
ADH , MANDHOO

CONTENTS: AS GIVEN

PROJECT MANAGER:

DESIGNER: ARIZ

CIV/STR. ENGINEER:

SURVEYED BY: -

DRAWN BY: ARIZ

CHECKED BY:

DATE : FEBRUARY 2021

SHEET NO. : /


PAPER SIZE: A3



ADMIN DIVISION
Ministry of Health
Roshanae Building
Sasun Alaga
Tel: 332 8887, Fax: 3328889

NURSE STATION COUNTER SECTION A-A

SCALE: 1 : 10

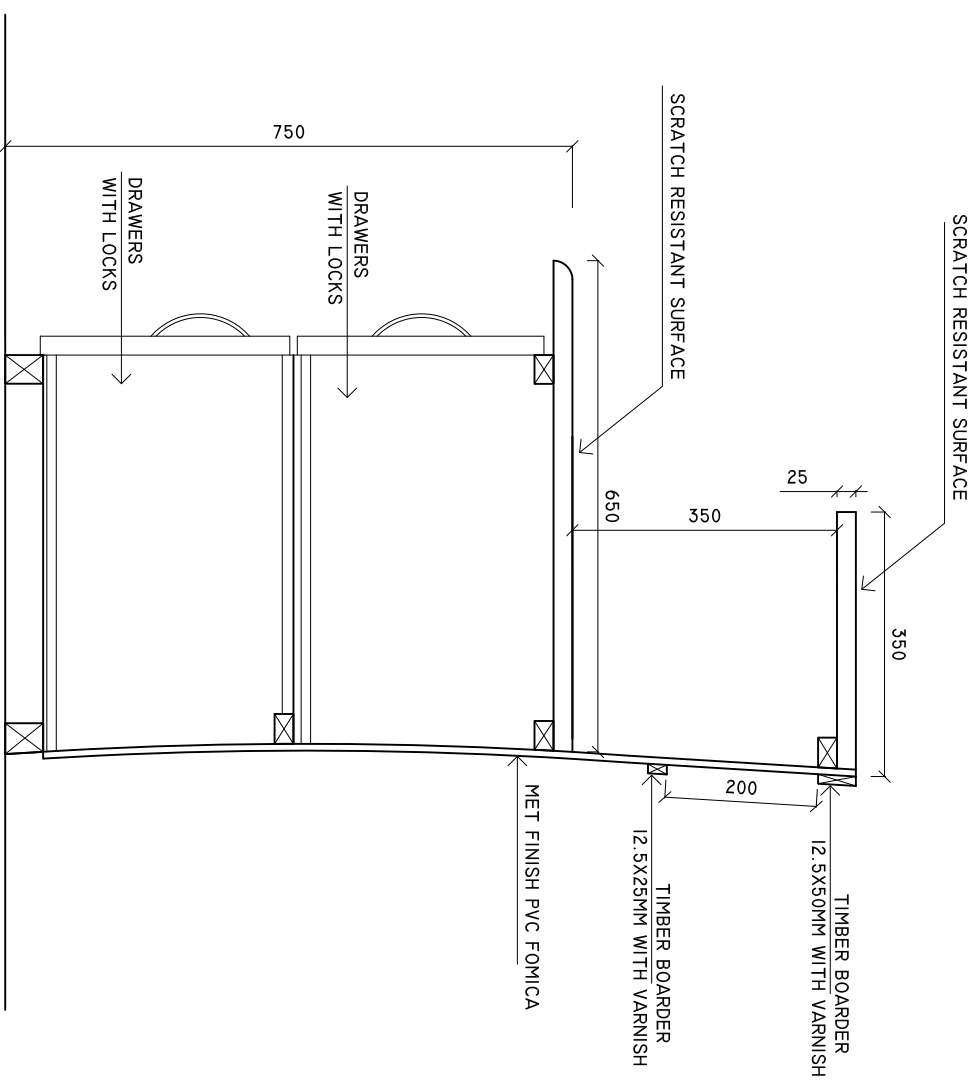

SHEET CONTENTS :

REVISION NOTES:

PROJECT:
EXTENSION OF ADH,
MANDHOO HEALTH
CENTER.

CLIENT:
MINISTRY OF HEALTH

LOCATION:
ADH , MANDHOO

CONTENTS: AS GIVEN

PROJECT MANAGER:

DESIGNER: ARIZ

CIV/STR. ENGINEER:

SURVEYED BY: -

DRAWN BY: ARIZ

CHECKED BY:


DATE : FEBRUARY 2021

SHEET NO. : /


PAPER SIZE: A3



**NURSE STATION
COUNTER SIDE VIEW**
SCALE: 1 : 10

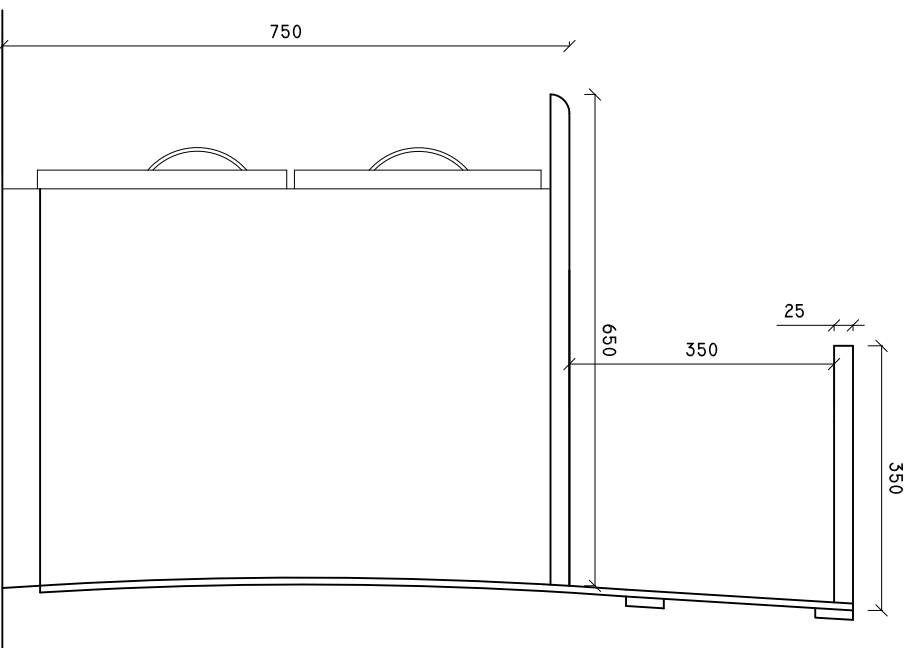

**NURSE STATION COUNTER
SECTION B-B**
SCALE: 1 : 10

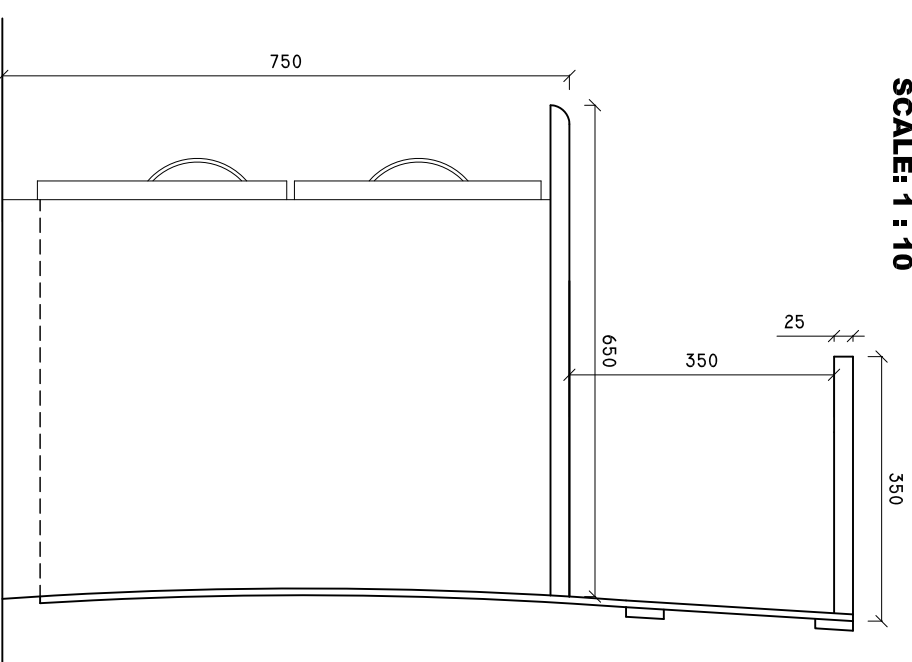

SHEET CONTENTS :

REVISION NOTES:

PROJECT:
EXTENSION OF ADH,
MANDHOO HEALTH
CENTER.

CLIENT:
MINISTRY OF HEALTH

LOCATION:
ADH , MANDHOO

CONTENTS: AS GIVEN

PROJECT MANAGER:

DESIGNER: ARIZ

CIV/STR. ENGINEER:

SURVEYED BY: -

DRAWN BY: ARIZ

CHECKED BY:

DATE : FEBRUARY 2021

SHEET NO. : /

PAPER SIZE: A3

