



**SITE PLAN**

SCALE: 1 : 100

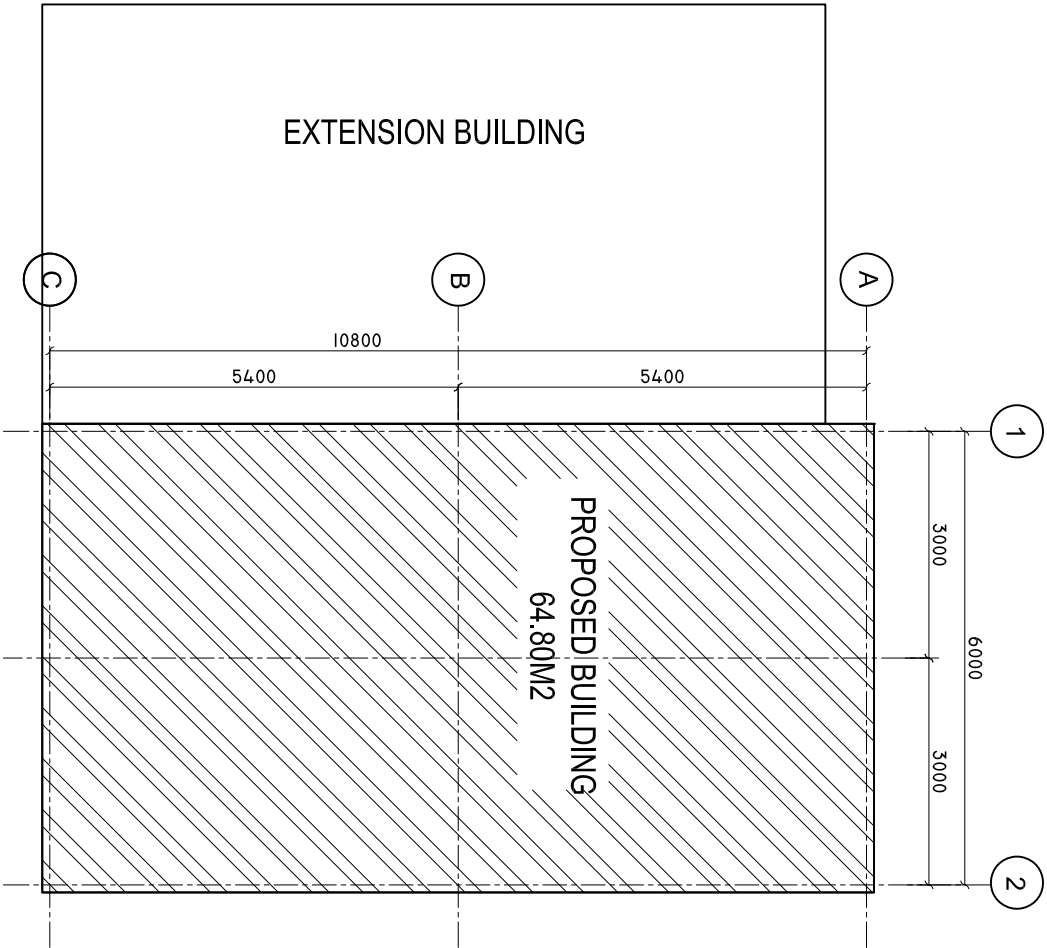

**PROPOSED CSSD FLOOR PLAN**

SCALE: 1 : 100

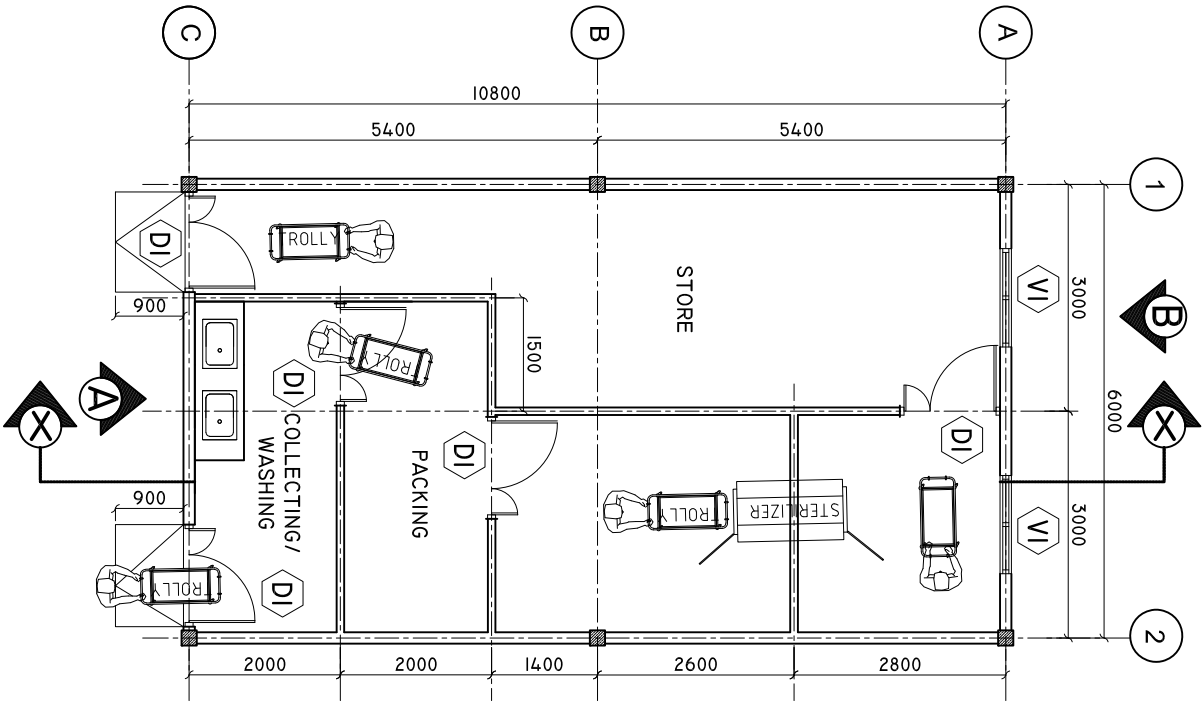

SHEET CONTENTS :

REVISION NOTES:

PROJECT:  
CONSTRUCTION OF  
CSSD AT DR. ABDUL  
SAMD MEMORIAL  
HOSPITAL

CLIENT:

MINISTRY OF HEALTH

LOCATION:

ADH. MANDHOO

CONTENTS: AS GIVEN

PROJECT MANAGER:

DESIGNER: ARIZ

CIV/STR. ENGINEER:

SURVEYED BY: -

DRAWN BY: ARIZ

CHECKED BY:

DATE : FEBRUARY 2021


SHEET NO. : /

PAPER SIZE: A3




# ELEVATION 'A'

SCALE: 1 : 100

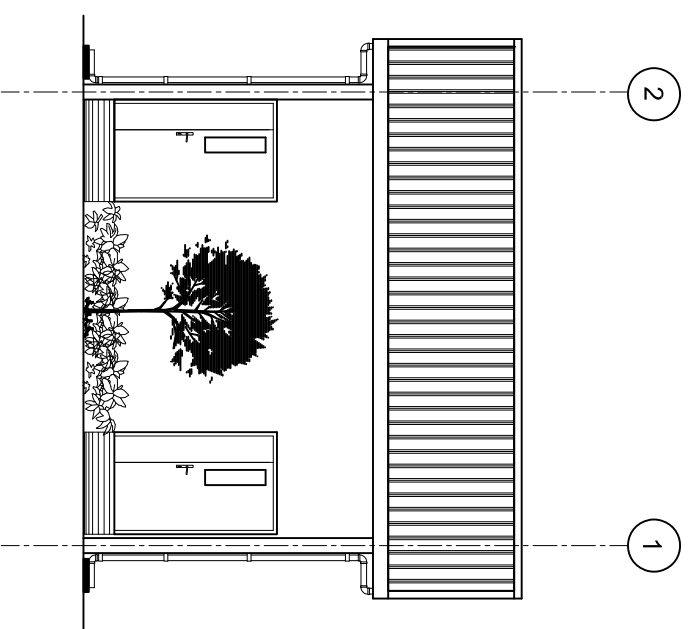


## WALL DETAILS

SCALE: 1 : 100

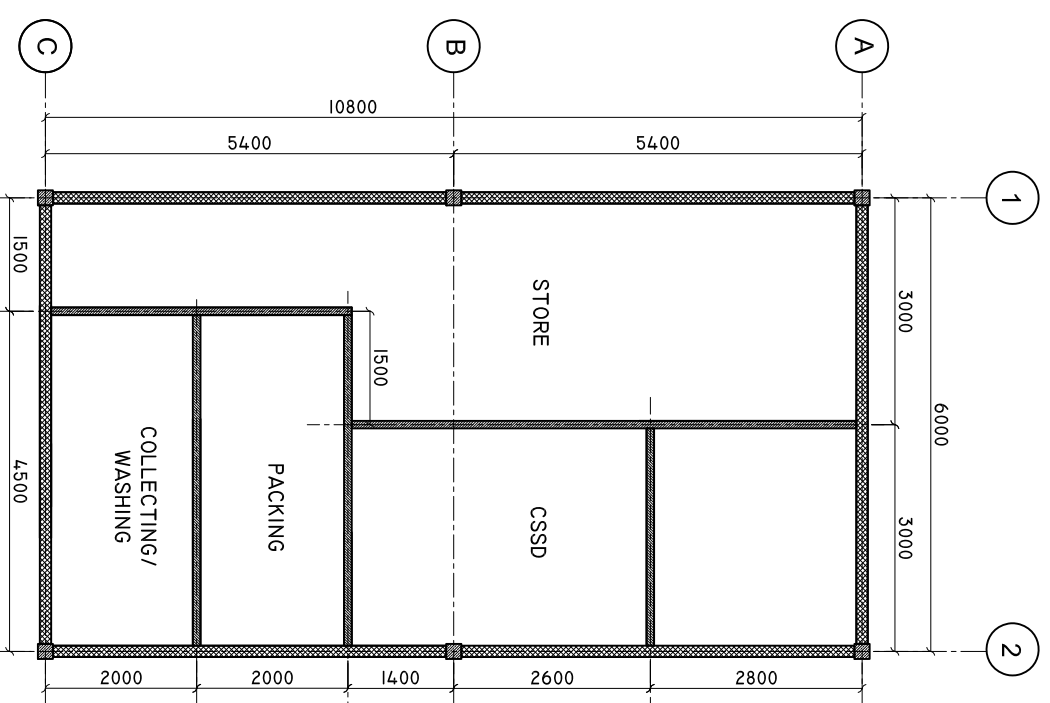

## ELEVATION 'B'

SCALE: 1 : 100

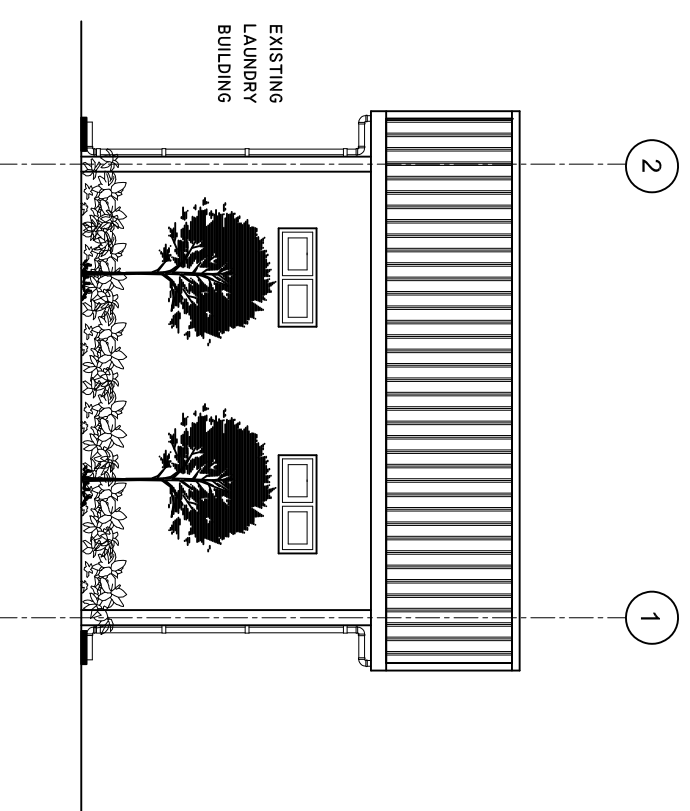


SHEET CONTENTS :
REVISION NOTES:
PROJECT: CONSTRUCTION OF CSSD AT DR. ABDUL SAMD MEMORIAL HOSPITAL
CLIENT:  MINISTRY OF HEALTH
LOCATION:  ADH . MANDHOO
CONTENTS: AS GIVEN
PROJECT MANAGER:
DESIGNER: ARIZ
CIVILSTR. ENGINEER:
SURVEYED BY: -
DRAWN BY: ARIZ
CHECKED BY:
DATE : FEBRUARY 2021
SHEET NO. : /
PAPER SIZE: A3



*ADMIN DIVISON  
Ministry of Health  
Roshanee Building  
Sosun Magu'*  
Tel: 332 8887, Fax: 3328889


ROOF PLAN

SCALE: 1 : 100

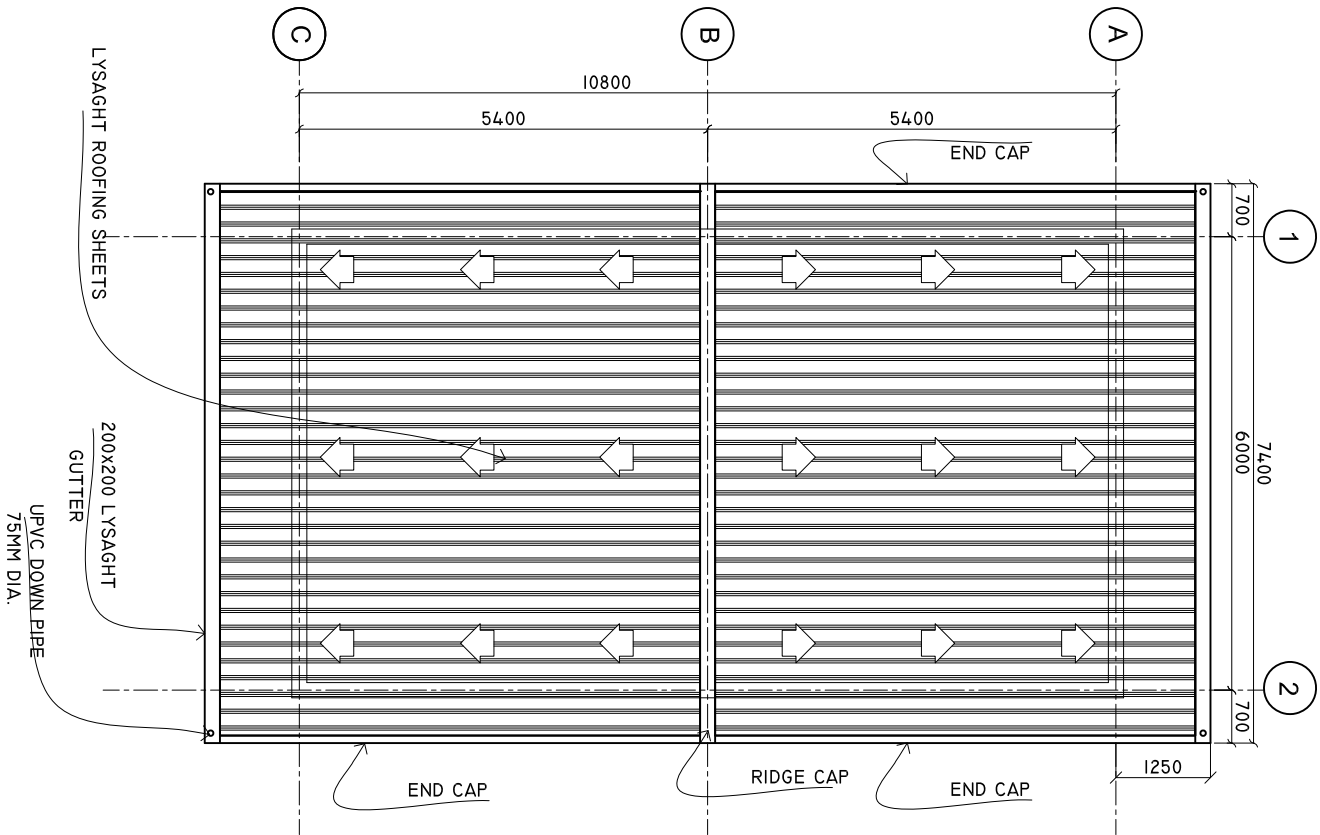

ROOF FRAMING PLAN

SCALE: 1 : 100

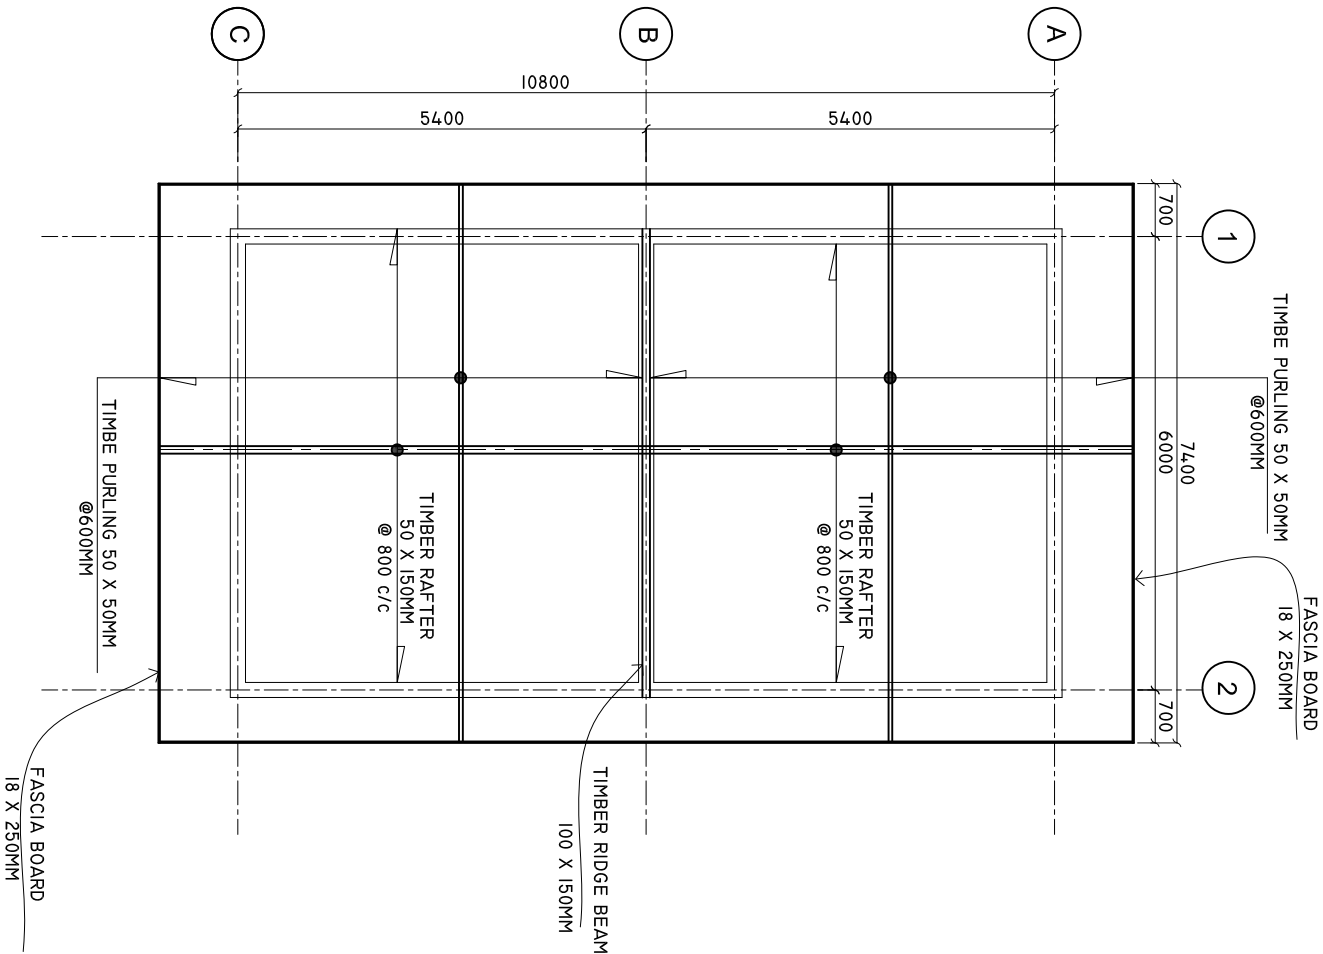

SHEET CONTENTS :

REVISION NOTES:

PROJECT:  
CONSTRUCTION OF  
CSSD AT DR. ABDUL  
SAMD MEMORIAL  
HOSPITAL

CLIENT:

MINISTRY OF HEALTH

LOCATION:

ADH. MANDHOO

CONTENTS: AS GIVEN

PROJECT MANAGER:

DESIGNER: ARIZ

CIV/STR. ENGINEER:

SURVEYED BY: -

DRAWN BY: ARIZ

CHECKED BY:

DATE : FEBRUARY 2021


SHEET NO. : /

PAPER SIZE: A3




COLUMN LAYOUT

SCALE: 1 : 100

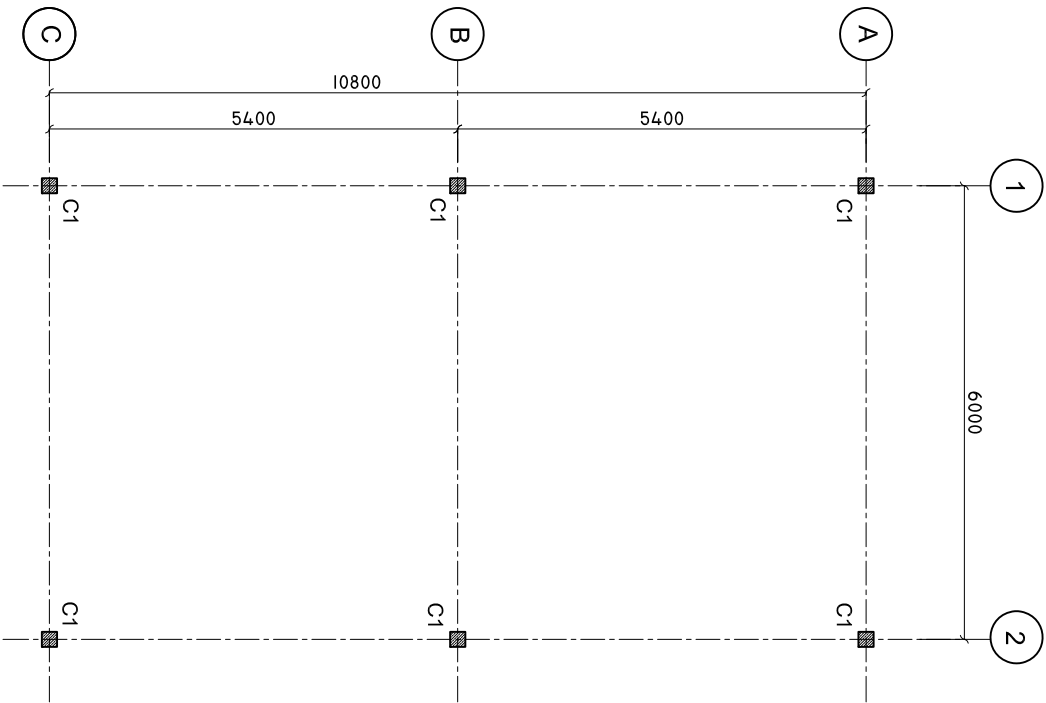

TIE BEAM PLAN

SCALE: 1 : 100

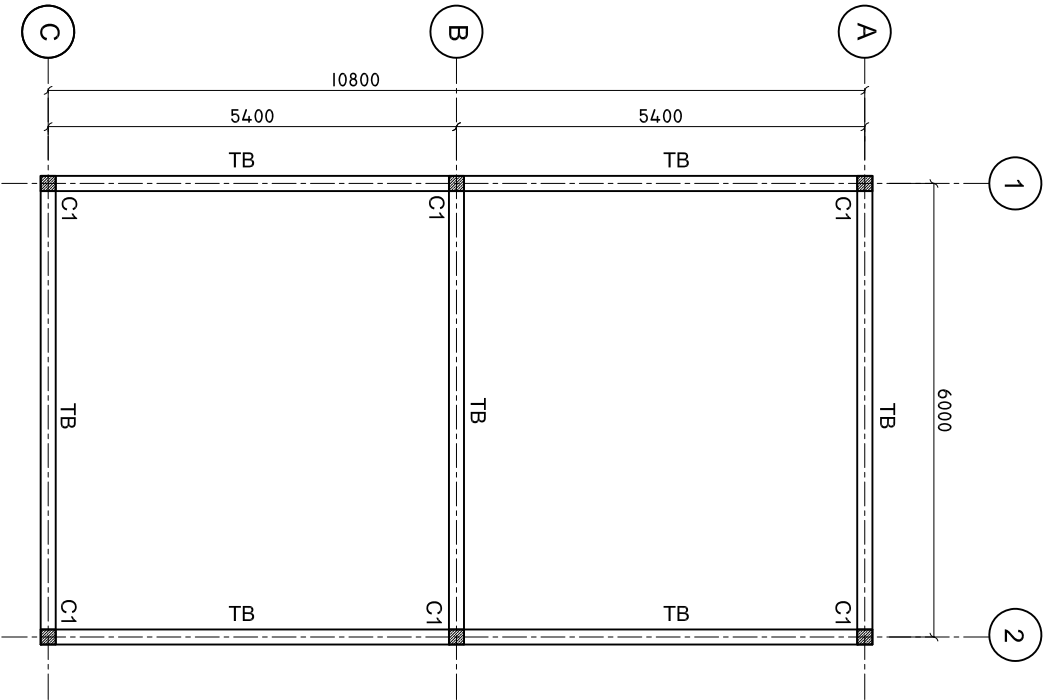

SHEET CONTENTS :

REVISION NOTES:

PROJECT:  
CONSTRUCTION OF  
CSSD AT DR. ABDUL  
SAMD MEMORIAL  
HOSPITAL

CLIENT:

MINISTRY OF HEALTH

LOCATION:

ADH . MANDHOO

CONTENTS: AS GIVEN

PROJECT MANAGER:

DESIGNER: ARIZ

CIV/STR. ENGINEER:

SURVEYED BY: -

DRAWN BY: ARIZ

CHECKED BY:

DATE : FEBRUARY 2021


SHEET NO. : /

PAPER SIZE: A3




ROOF BEAM PLAN

SCALE: 1 : 100

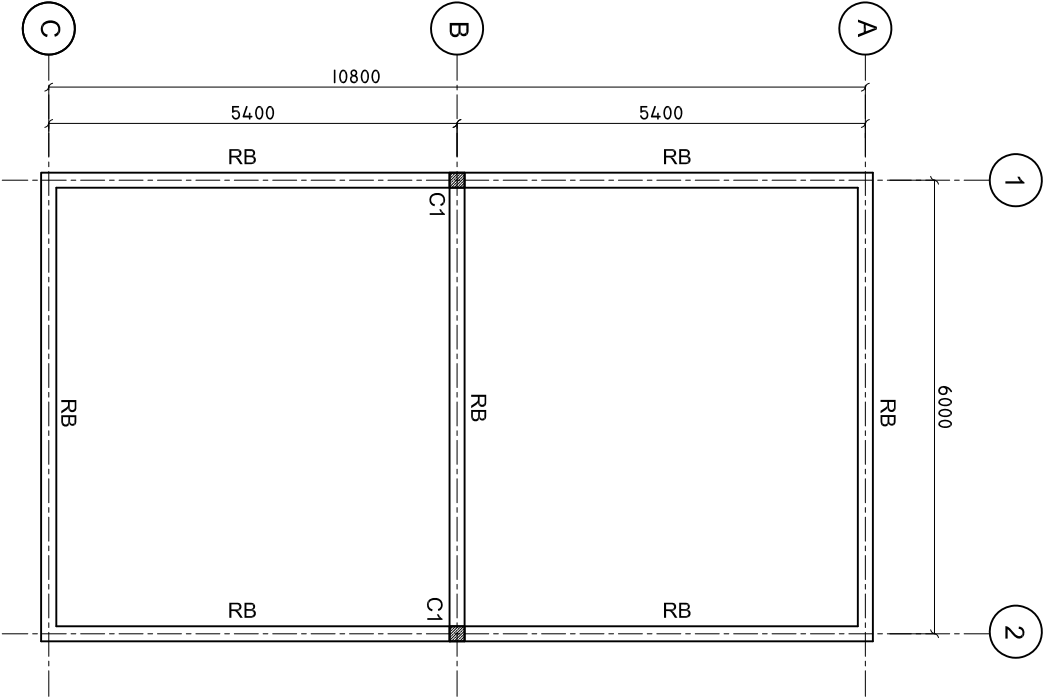

DETAILS R/C

SCALE: 1 : 25

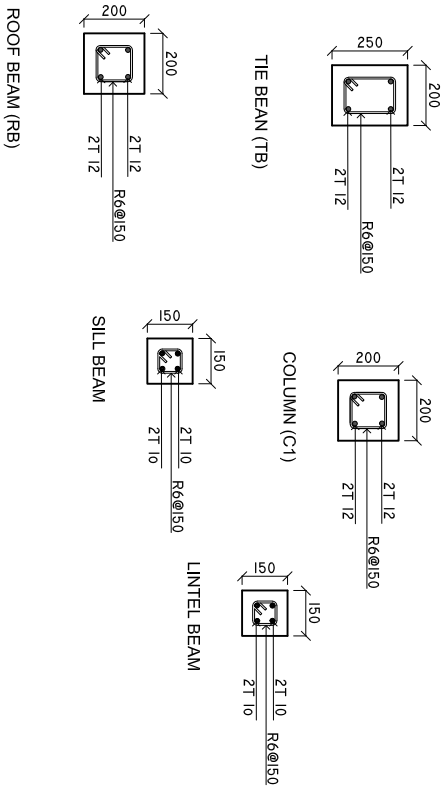

MINIMUM 50MM COVER BELOW GROUND LEVEL	ALL BAR BENDING & OVERLAPS AS PER ACTUAL BS STANDARD.
MINIMUM 30MM COVER ABOVE GROUND LEVEL	

NOTE:  
LINTEL BEAMS TO BE LAID ABOVE AND BELOW ALL WINDOWS AND ALL DOORS.

SHEET CONTENTS :

REVISION NOTES:

PROJECT:  
CONSTRUCTION OF  
CSSD AT DR. ABDUL  
SAMD MEMORIAL  
HOSPITAL

CLIENT:

MINISTRY OF HEALTH

LOCATION:

ADH . MANDHOO

CONTENTS: AS GIVEN

PROJECT MANAGER:

DESIGNER: ARIZ

CIV/STR. ENGINEER:

SURVEYED BY: -

DRAWN BY: ARIZ

CHECKED BY:

DATE : FEBRUARY 2021


SHEET NO. : /

PAPER SIZE: A3



ELECTRICAL LAYOUT

SCALE: 1 : 100

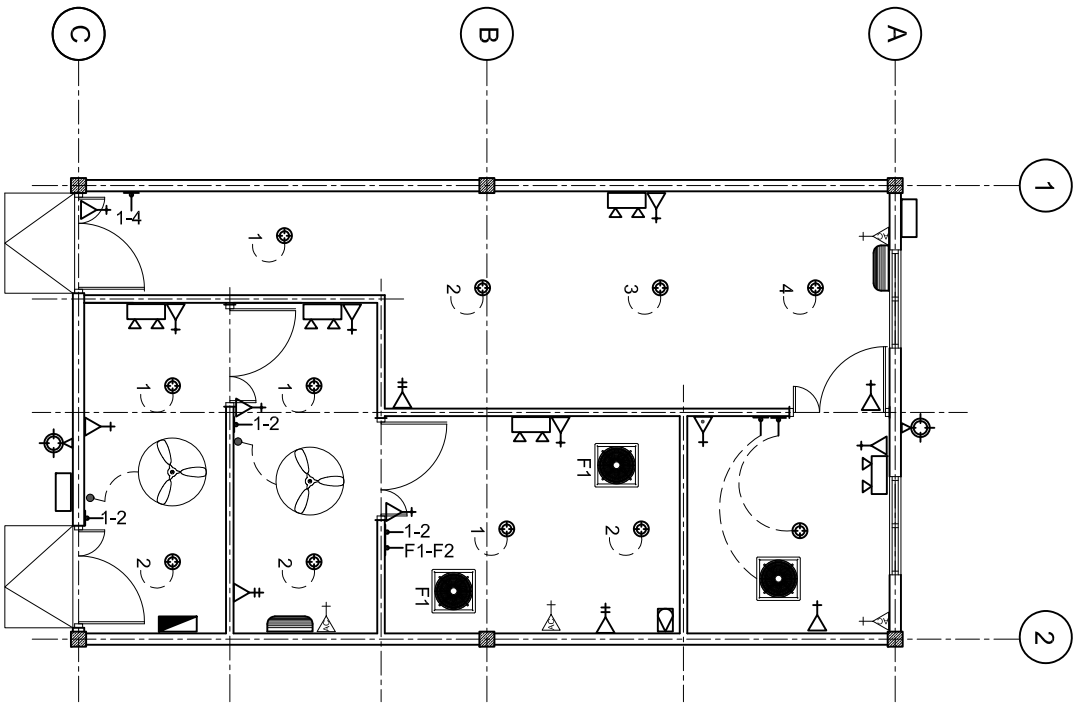

LEGEND

SYMBOL	DESCRIPTION
	LED BULB WITH 200MM DOWN LIGHT
	1 x 13 AMP SOCKET OUTLET (1600MM ABOVE FFL)
	2 x 13 AMP SOCKET OUTLET (600MM ABOVE FFL)
	1 x 15 AMP SOCKET OUTLET (600MM ABOVE FFL)
	1 x 15 AMP AC SOCKET OUTLET ( 300MM BLW, CEILING)
	TWO GANG SWITCH
	ONE WAY SWITCH
	EMERGENCY LIGHT
	DISTRIBUTION BOARD ( WALL EMBEDDED )
	AC WALL MOUNT UNIT
	3 PHASE ISOLATOR
	HEAVY DUTY EXHAUST FAN (CEILING)
	FAN REGULATOR
	CEILING FAN 900MM DIA.
	OUTDOOR LIGHT
	AC OUT DOOR UNIT
	METER WITH OUT DOOR WATER PROOF BOX WITH TRANSPARENT FRONT DOOR

SHEET CONTENTS :

REVISION NOTES:

PROJECT:  
CONSTRUCTION OF  
CSSD AT DR. ABDUL  
SAMD MEMORIAL  
HOSPITAL

CLIENT:

MINISTRY OF HEALTH

LOCATION:

ADH . MANDHOO

CONTENTS: AS GIVEN

PROJECT MANAGER:

DESIGNER: ARIZ

CIV/STR. ENGINEER:

SURVEYED BY: -

DRAWN BY: ARIZ

CHECKED BY:

DATE : FEBRUARY 2021

SHEET NO. : /

PAPER SIZE: A3



# DOORS AND WINDOWS SCHEDULE

Scale 1:50

SYMBOL	D1	V1
ELEVATION		
LOCATION	GROUND FLOOR	GROUND FLOOR
QUANTITY	00 NOS.	00 NOS.
FRAME	ALUMINUM FRAME DOOR	ALUMINUM FRAME DOOR
PANEL	ALUMINUM 60-80 MICRON POWDER COATING	ALUMINUM 60-80 MICRON POWDER COATING
FINISH	ALUMINUM IN 60-80 MICRON POWDER COATING	ALUMINUM IN 60-80 MICRON POWDER COATING
HINGE	STAINLESS STEEL	STAINLESS STEEL
LOCK	STATE MAKE	STATE MAKE
NOTE	ALL MEASUREMENTS TO BE CHECKED ON SITE	ALL MEASUREMENTS TO BE CHECKED ON SITE

NOTE:

PROVIDE RC LINTEL ABOVE ALL  
DOOR/WINDOW/VENTILATOR UNITS NOT FIXED TO BEAMS  
AND PROVIDE RC SILL BEAMS UNDER ALL WINDOW UNITS  
ALL TIMBER DOORS TO BE MADE OF TIMBER, PUTTY  
SMOOTHED AND FINISHED WITH ENAMEL PAINT AS  
SPECIFIED

GL = 6MM TINTED LAMINATED GLASS  
CL = 5 CLADDING SHEET, WHITE POWDER COATED ON BOTH SIDE  
DOUBLE GLAZING

ALL THE ALUMINUM PROFILE MUST BE MINIMUM 2MM THICK.


SHEET CONTENTS :
REVISION NOTES:
PROJECT: CONSTRUCTION OF CSSD AT DR. ABDUL SAMD MEMORIAL HOSPITAL
CLIENT:  MINISTRY OF HEALTH
LOCATION:  ADH . MANDHOO
CONTENTS: AS GIVEN
PROJECT MANAGER:
DESIGNER: ARIZ
CIV/STR. ENGINEER:
SURVEYED BY : -
DRAWN BY: ARIZ
CHECKED BY:
DATE : FEBRUARY 2021
SHEET NO. : /
PAPER SIZE: A3



*ADMIN DIVISON  
Ministry of Health  
Roshane Building  
Sasum Magu'  
Tel: 332 8887, Fax: 3328889*

# CROSS SECTION X-X

SCALE: 1 : 50

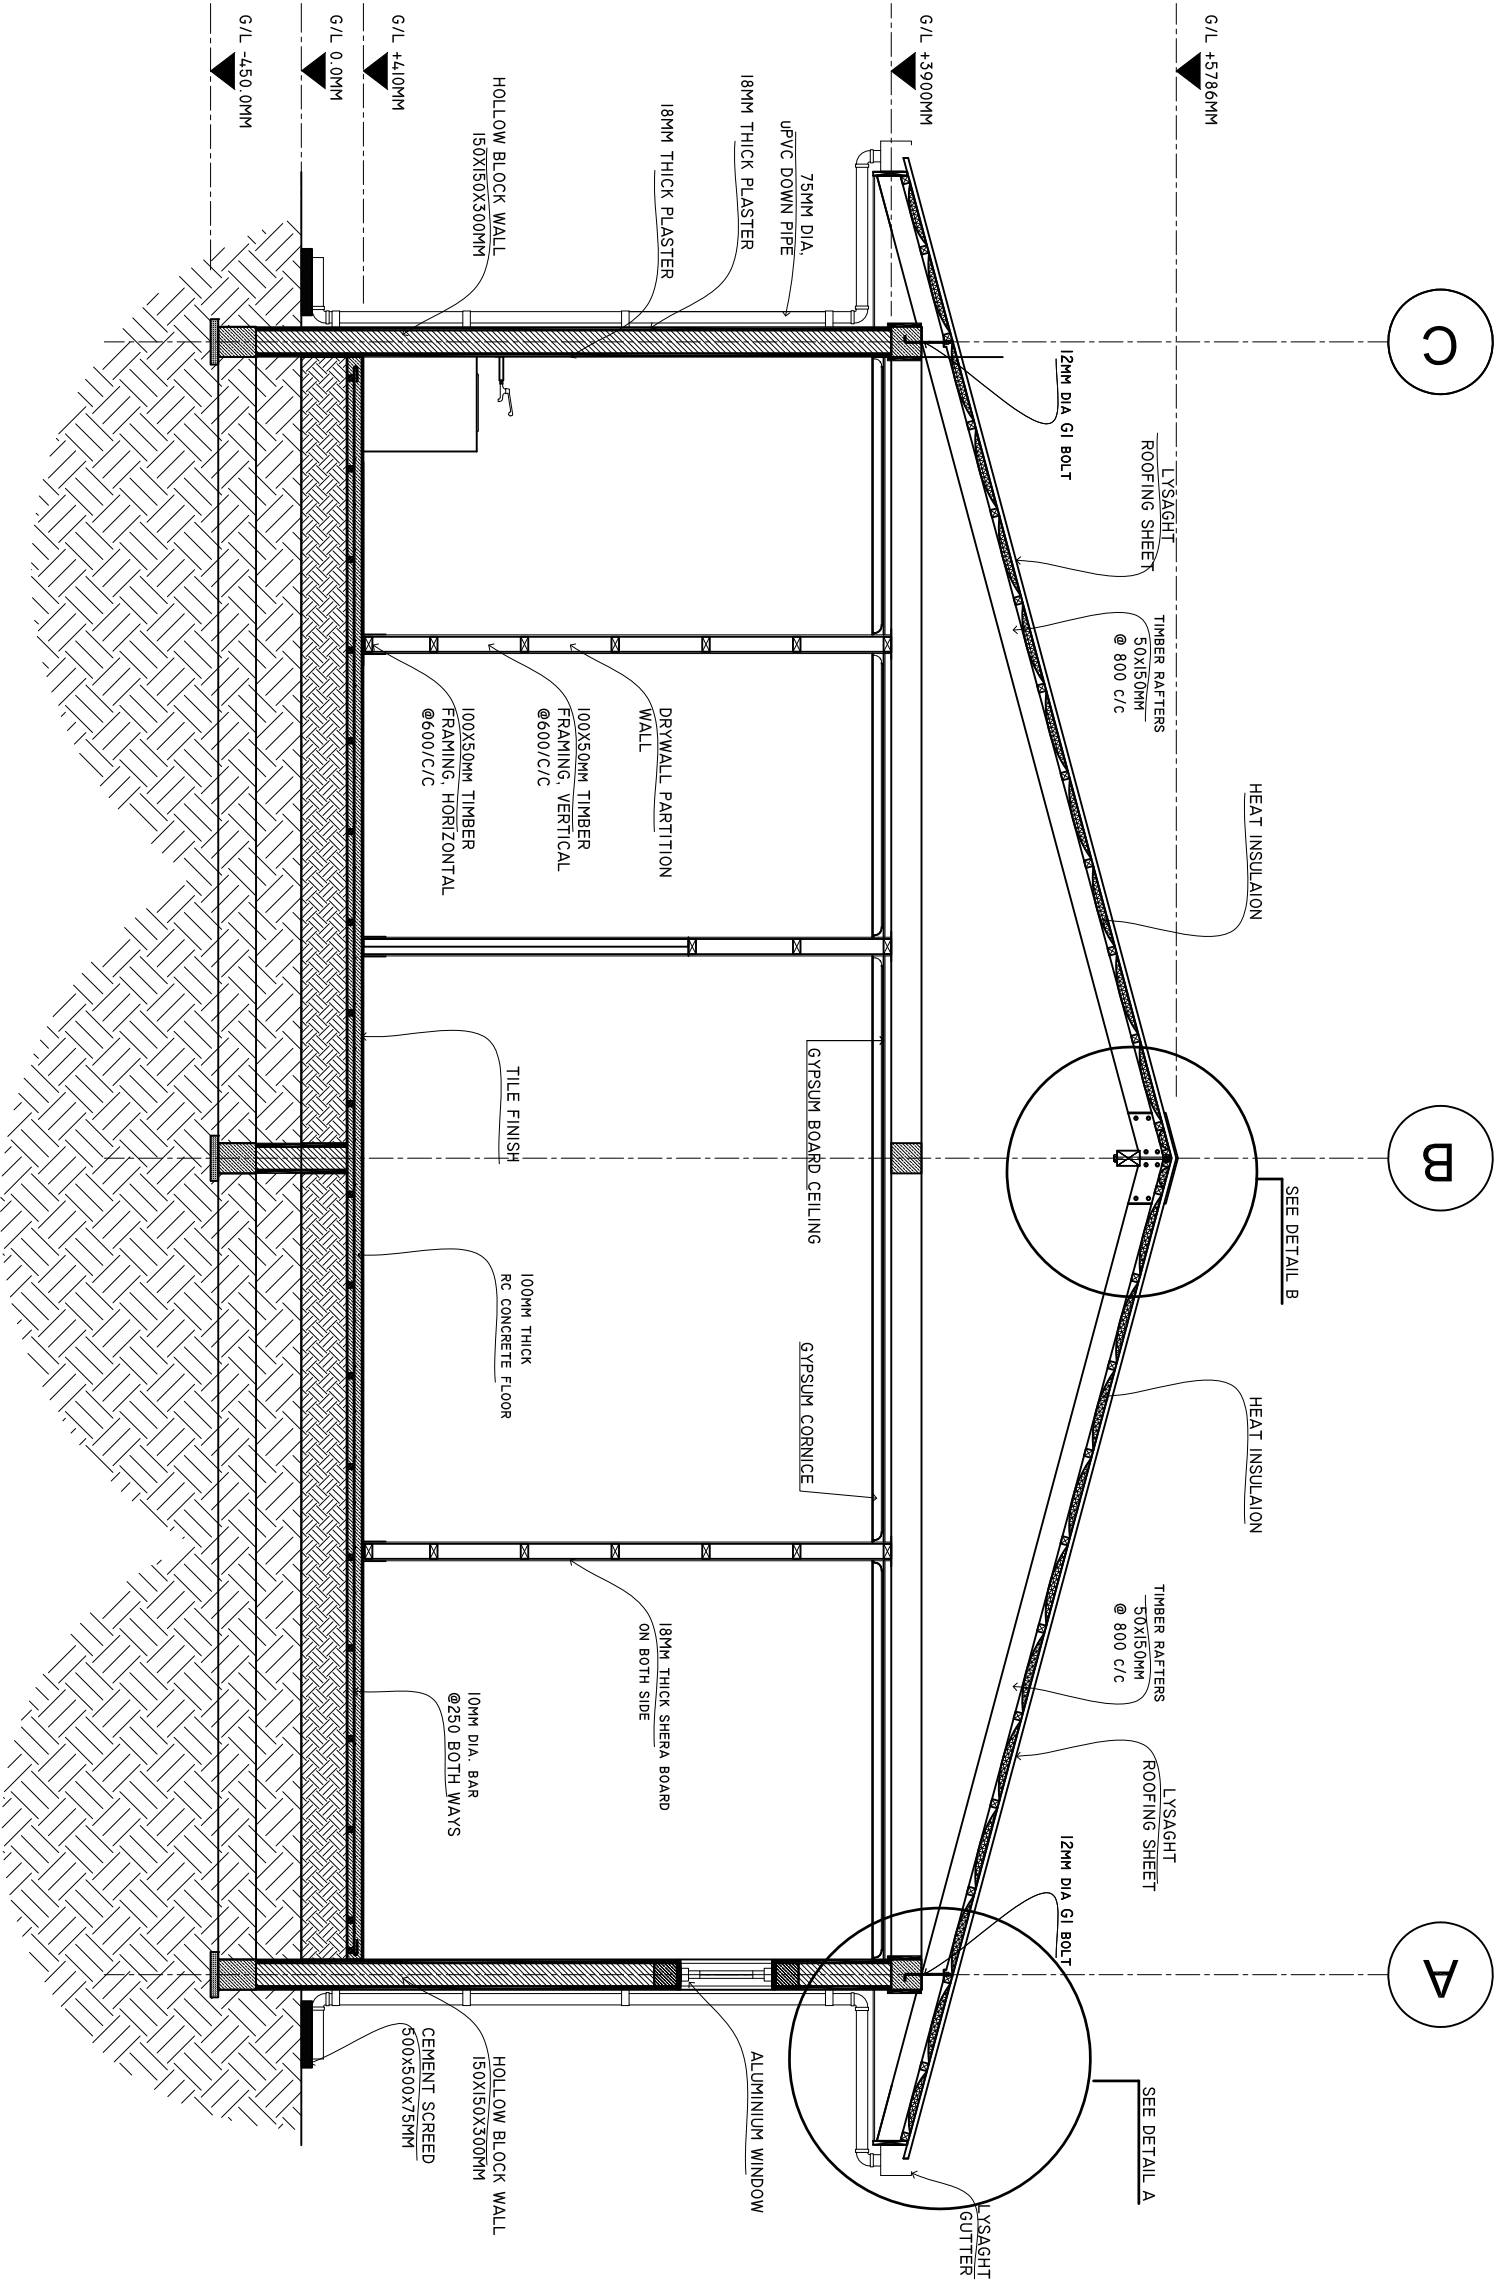

SHEET CONTENTS :

REVISION NOTES:

PROJECT:  
CONSTRUCTION OF  
CSSD AT DR. ABDUL  
SAMD MEMORIAL  
HOSPITAL

CLIENT:

MINISTRY OF HEALTH

LOCATION:

ADH. MANDHOO

CONTENTS: AS GIVEN

PROJECT MANAGER:

DESIGNER: ARIZ

CIV/STR. ENGINEER:

SURVEYED BY: -

DRAWN BY: ARIZ

CHECKED BY:

DATE : FEBRUARY 2021

SHEET NO. : /


PAPER SIZE: A3



ADMIN DIVISION  
Ministry of Health  
Roshanra Building  
Sasun Nagar  
Tel: 332 8887, Fax: 3328889



**DETAIL A**  
**SCALE: 1 : 10**

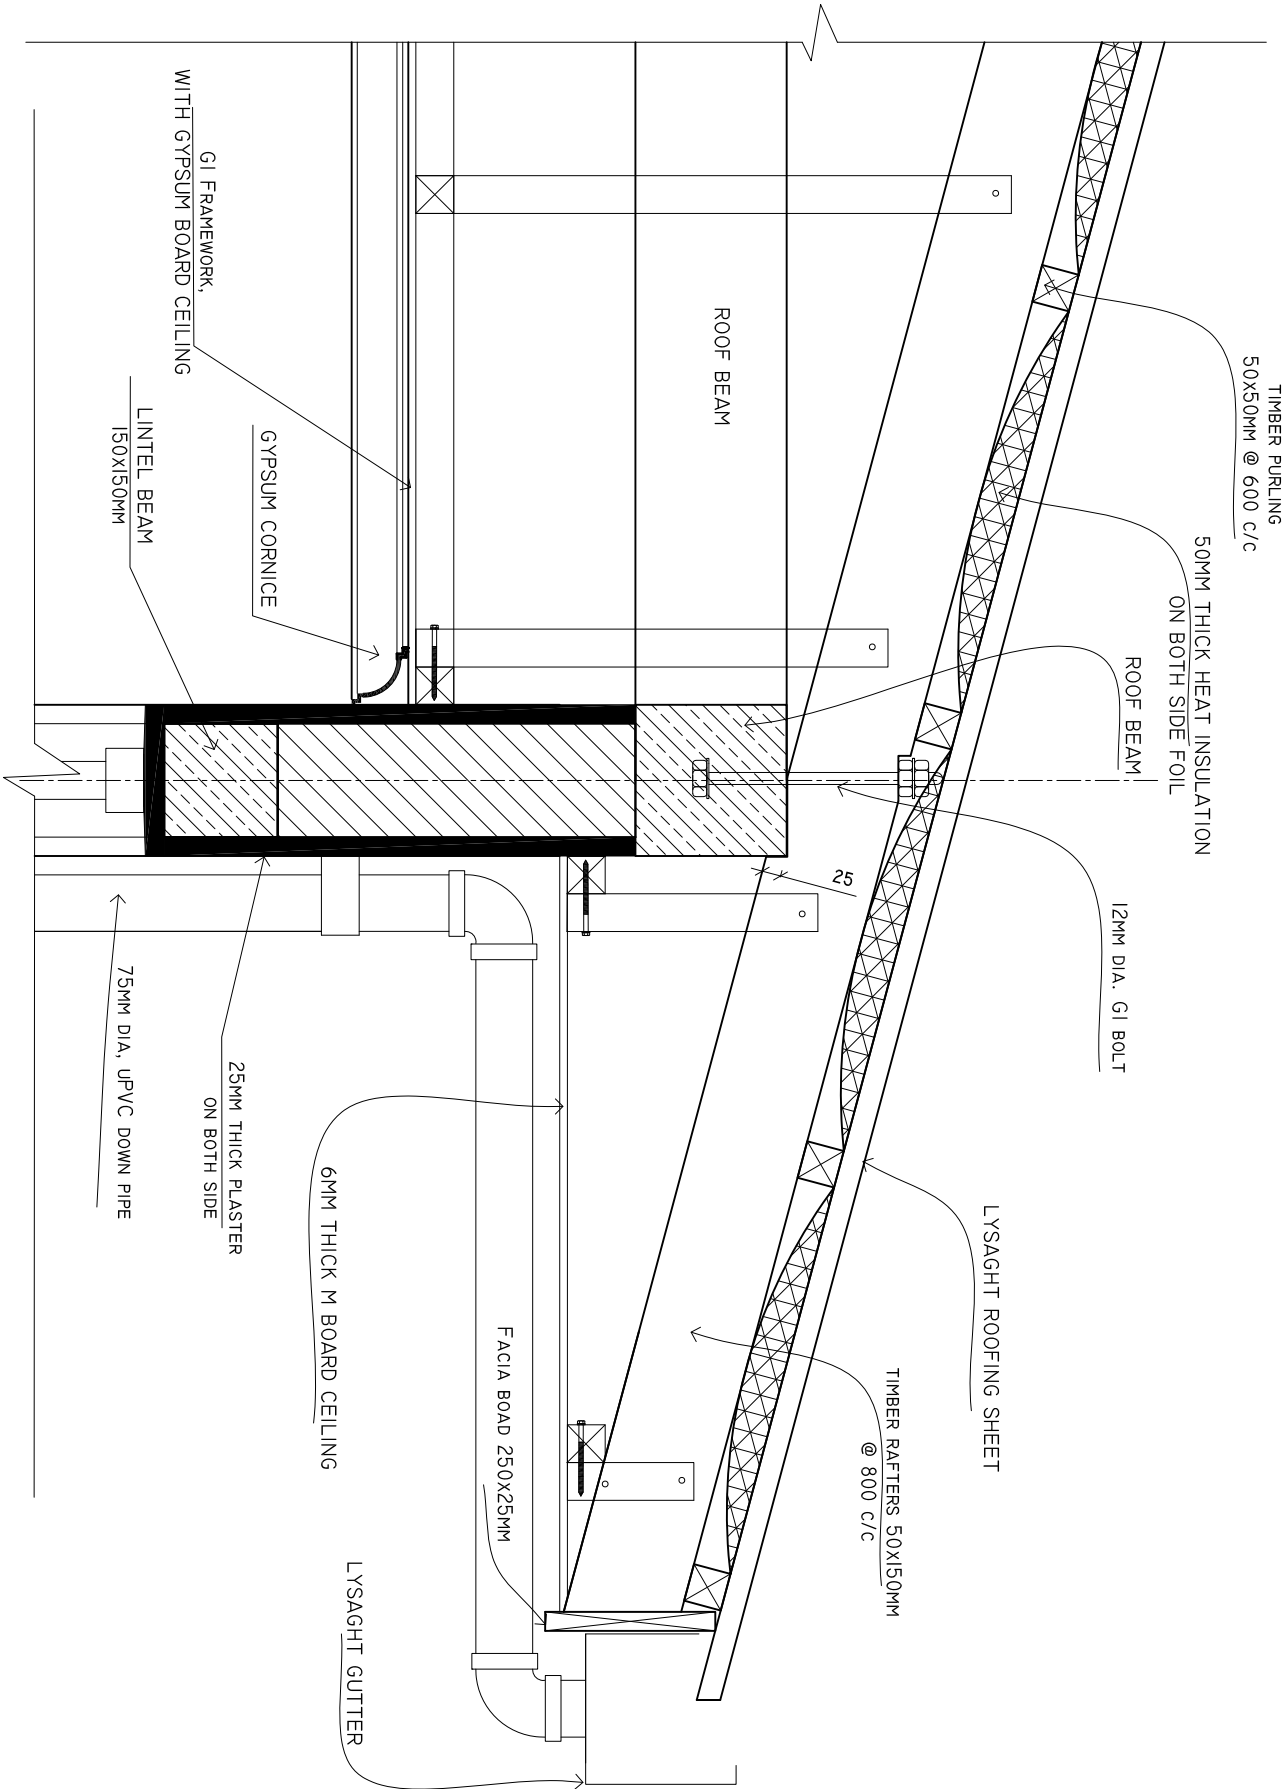

SHEET CONTENTS :

REVISION NOTES:

PROJECT:  
CONSTRUCTION OF  
CSSD AT DR. ABDUL  
SAMD MEMORIAL  
HOSPITAL

CLIENT:

MINISTRY OF HEALTH

LOCATION:

ADH. MANDHOO

CONTENTS: AS GIVEN

PROJECT MANAGER:

DESIGNER: ARIZ

CIV/STR. ENGINEER:

SURVEYED BY: -

DRAWN BY: ARIZ

CHECKED BY:

DATE : FEBRUARY 2021


SHEET NO. : /

PAPER SIZE: A3



DETAIL B

SCALE: 1 : 10

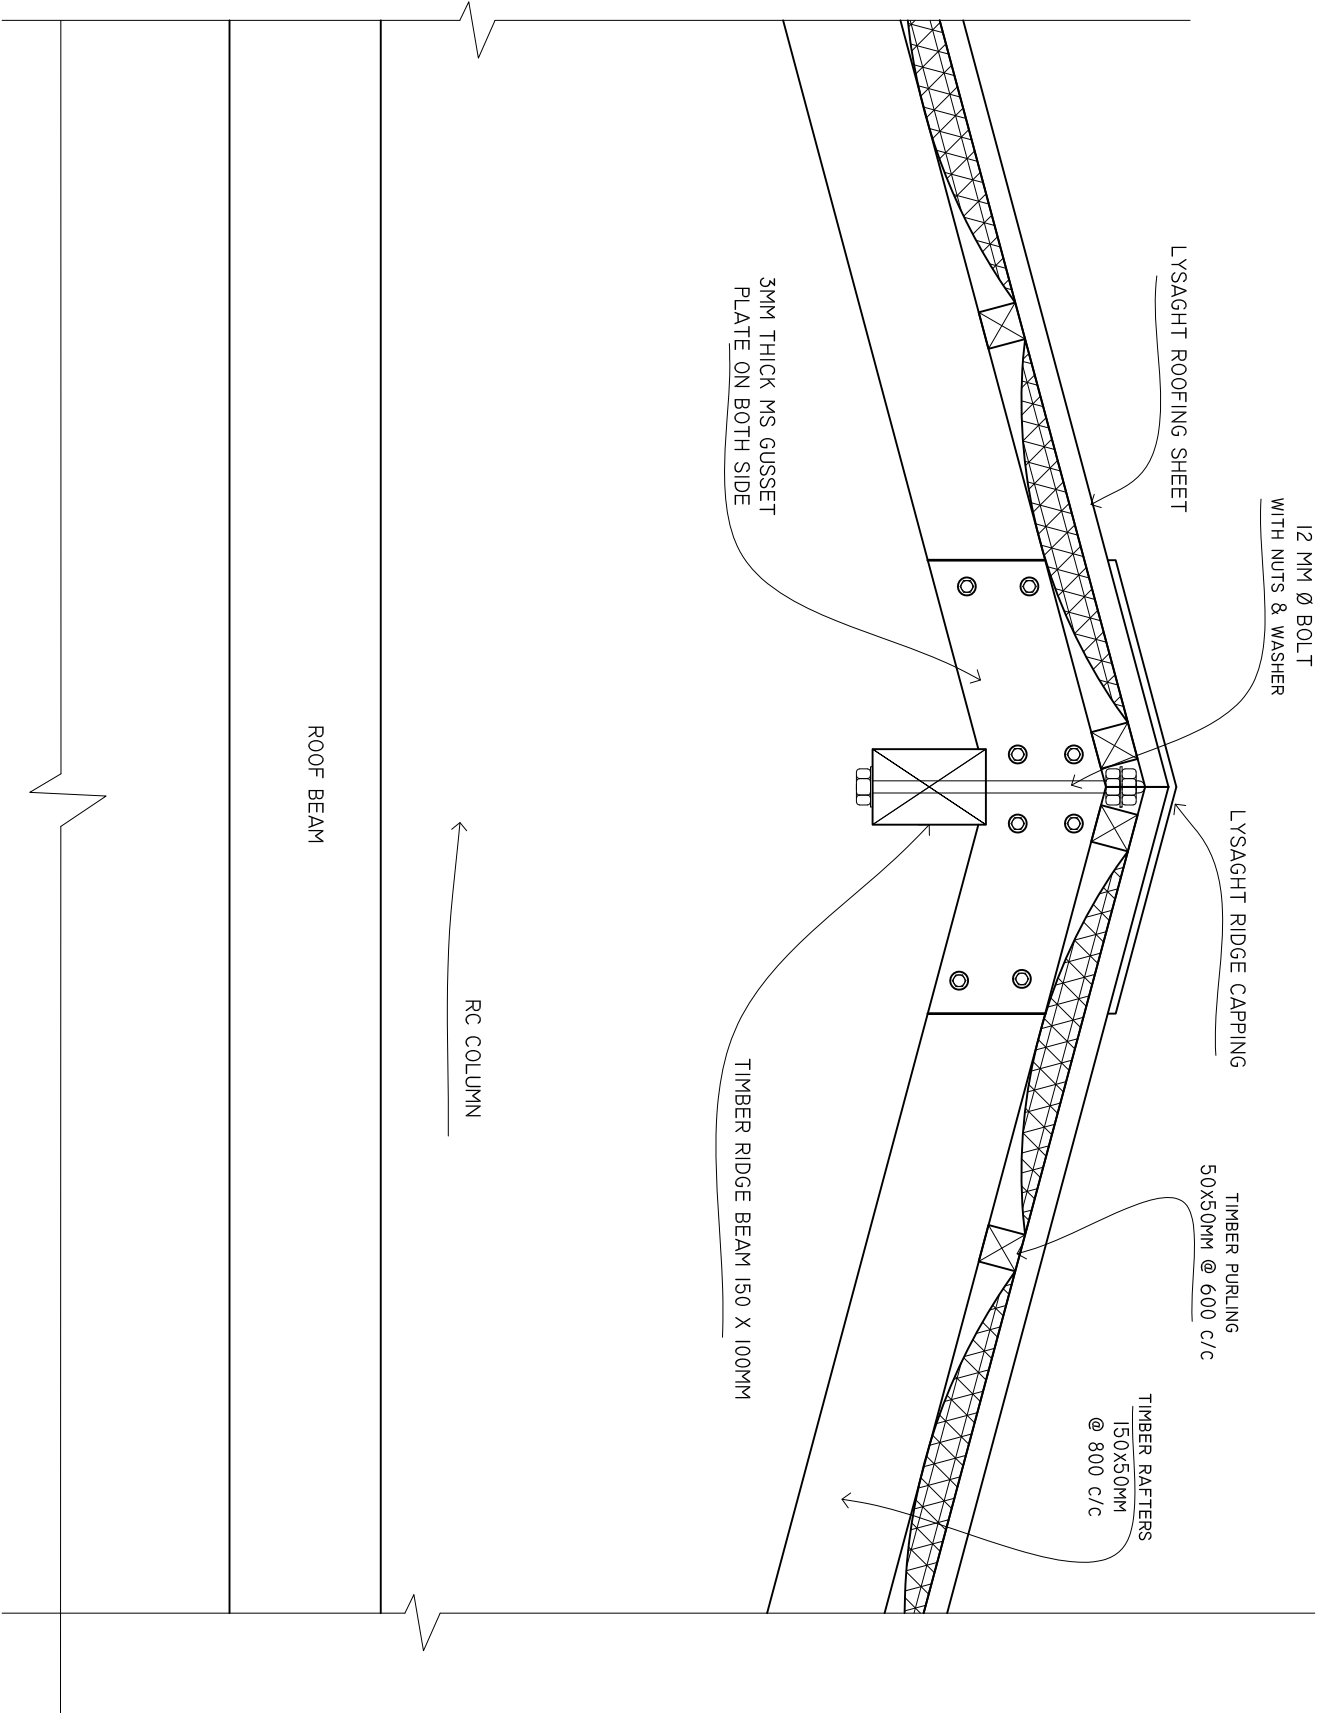

SHEET CONTENTS :

REVISION NOTES:

PROJECT:  
CONSTRUCTION OF  
CSSD AT DR. ABDUL  
SAMD MEMORIAL  
HOSPITAL

CLIENT:

MINISTRY OF HEALTH

LOCATION:

ADH. MANDHOO

CONTENTS: AS GIVEN

PROJECT MANAGER:

DESIGNER: ARIZ

CIV/STR. ENGINEER:

SURVEYED BY: -

DRAWN BY: ARIZ

CHECKED BY:


DATE : FEBRUARY 2021

SHEET NO. : /

PAPER SIZE: A3




# SINK CUPBOARD

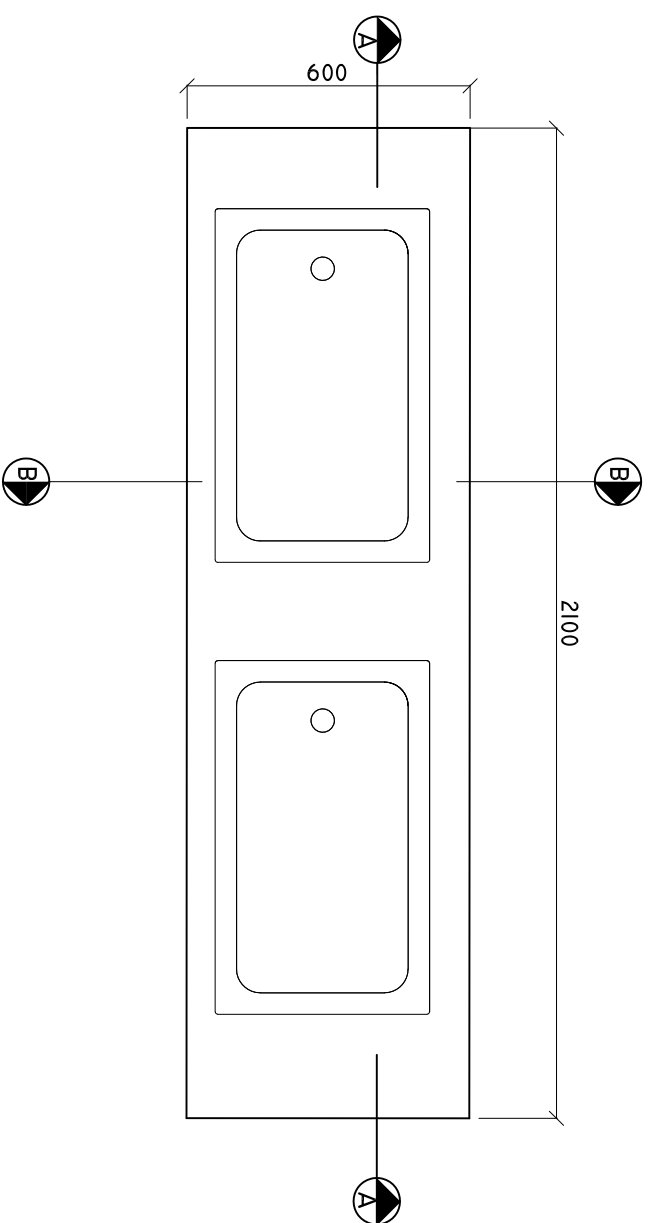

**NOTE: PLEASE CHECK ALL MESUREMENTS ON SITE BEFORE CARRYING OUT WORK**

# SINK CUPBOARD SECTION A-A

**SCALE: 1 : 20**

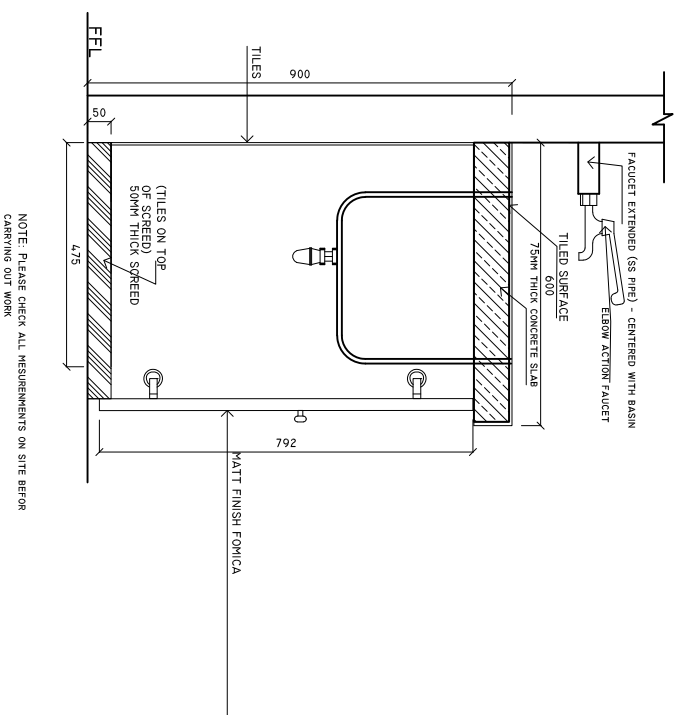


NOTE: PLEASE CHECK ALL MESUREMENTS ON SITE BEFORE CARRYING OUT WORK

## **SINK CUPBOARD**

---

### **DETAIL B-B**


**SCALE: 1 : 20**

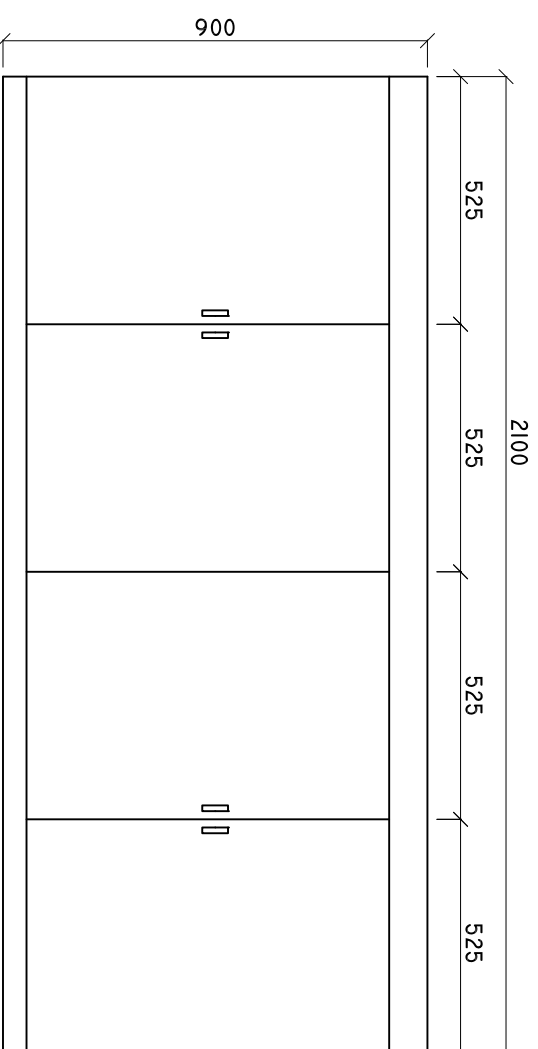

**NOTE: PLEASE CHECK ALL MESUREMENTS ON SITE BEFOR CARRYING OUT WORK**

## SINK CUPBOARD ELEVATION

**SCALE: 1 : 20**

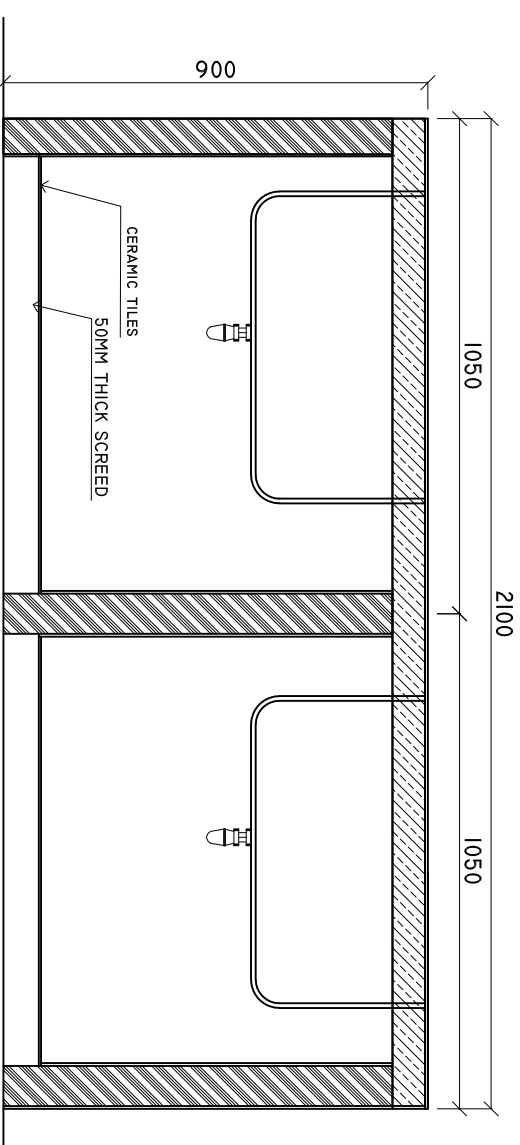

NOTE: PLEASE CHECK ALL MESUREMENTS ON SITE BEFOR CARRYING OUT WORK

## SINK CUPBOARD DETAIL A-A

**SCALE: 1 : 20**

SHEET CONTENTS :
REVISION NOTES:
PROJECT: CONSTRUCTION OF CSSD AT DR. ABDUL SAMD MEMORIAL HOSPITAL
CLIENT:  MINISTRY OF HEALTH
LOCATION:  ADH . MANDHOO
CONTENTS : AS GIVEN
PROJECT MANAGER:
DESIGNER: ARIZ
CIVILSTR. ENGINEER:
SURVEYED BY: -
DRAWN BY: ARIZ
CHECKED BY:
DATE : FEBRUARY 2021
SHEET NO. : /
PAPER SIZE: A3



*ADMIN DIVISON  
Ministry of Health  
Roshanee Building  
Sosun Magu'  
Tel: 332 8887, Fax: 3328888*