


SITE PLAN

SCALE: 1 : 100

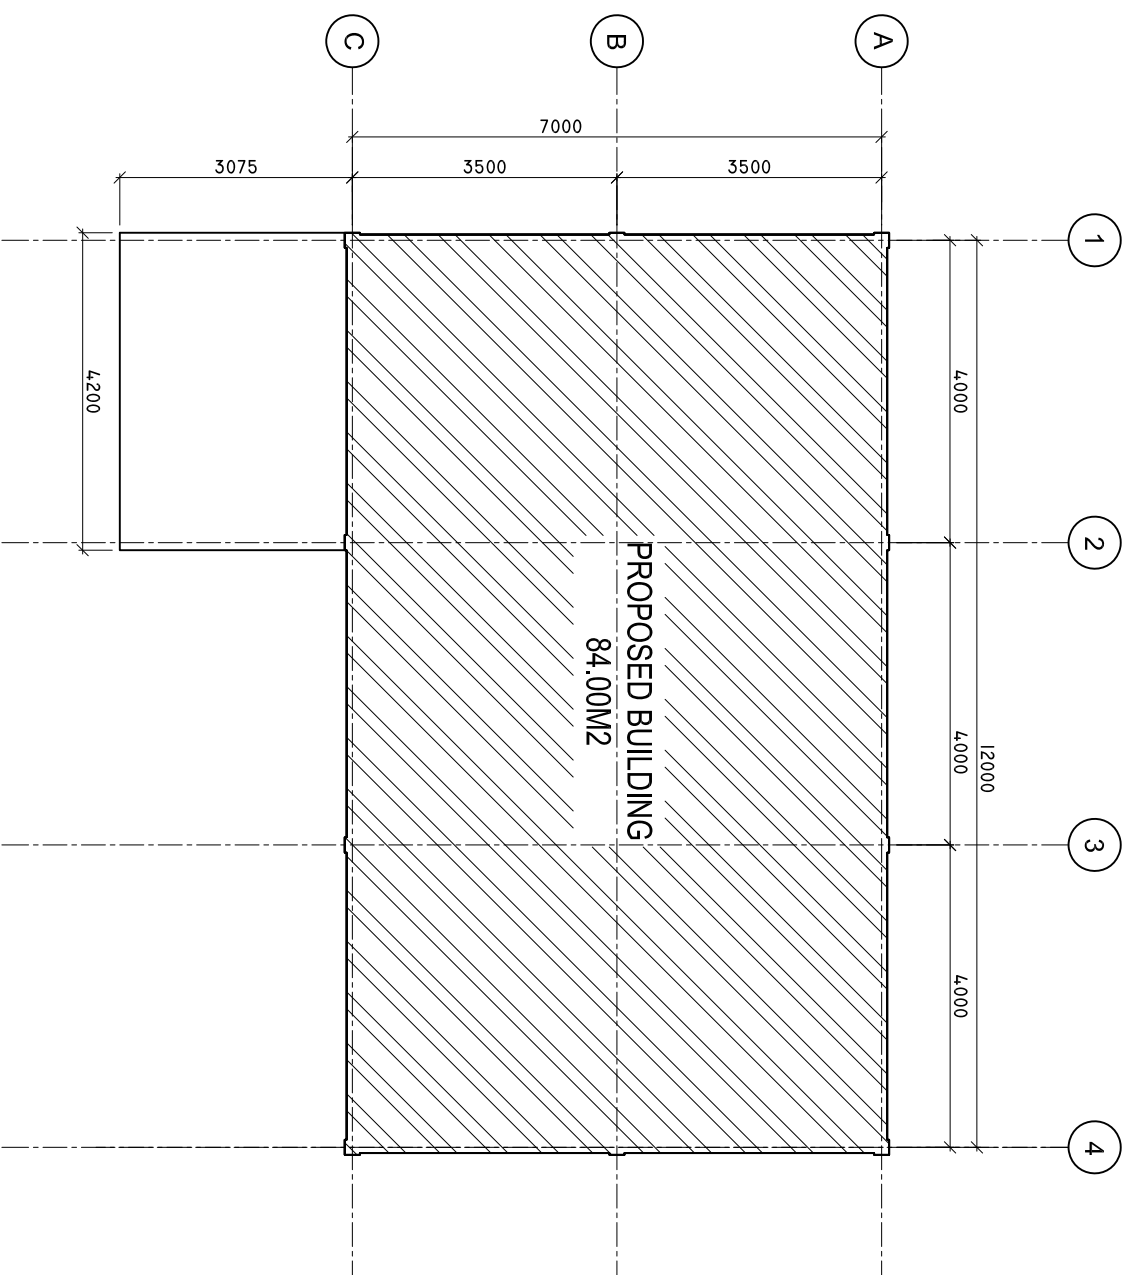

SHEET CONTENTS :

REVISION NOTES:

PROJECT:
CONSTRUCTION OF
SERVICES BUILDING

CLIENT:
MINISTRY OF HEALTH

LOCATION:
MULTIPLE ISLANDS

CONTENTS: AS GIVEN


PROJECT MANAGER:
DESIGNER: ARIZ
CIV/STR. ENGINEER:
SURVEYED BY: -
DRAWN BY: ARIZ
CHECKED BY:
DATE : DEC 2020
PAPER SIZE : A3
SHEET NO. : /



ADMIN DIVISION
Ministry of Health
Roshanae Building
Soana Maaga
Tel: 332 8887, Fax: 332 8889

FLOOR PLAN

SCALE: 1 : 100

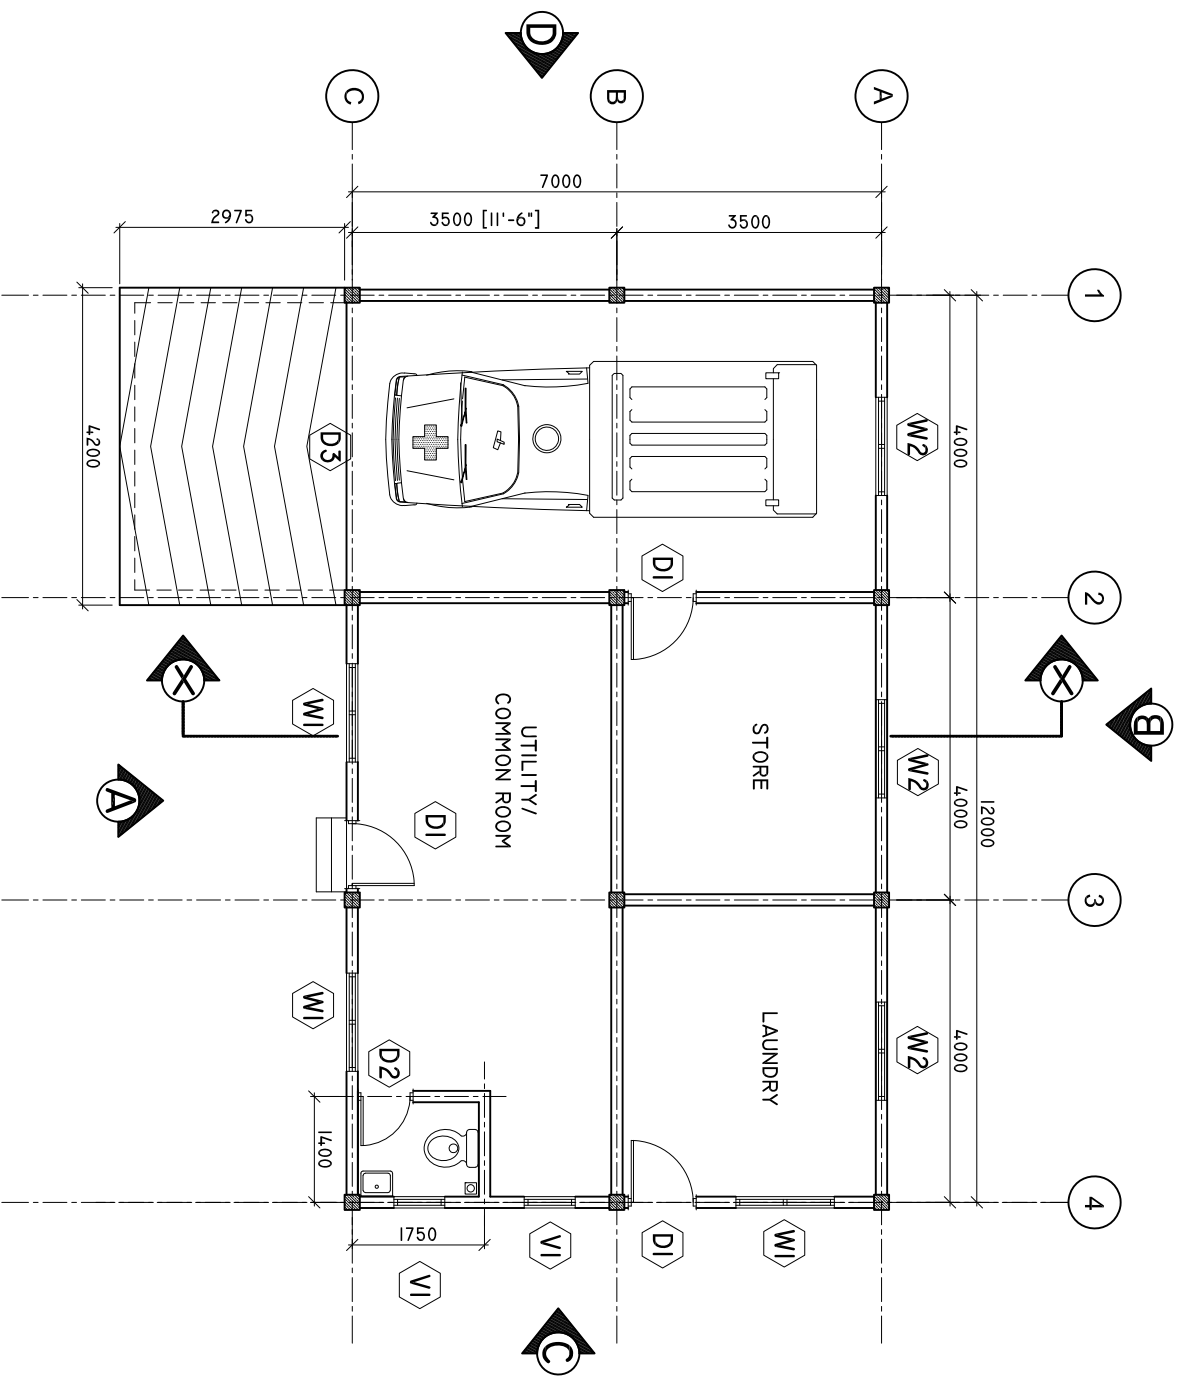

SHEET CONTENTS :

REVISION NOTES:

PROJECT:
CONSTRUCTION OF
SERVICE BUILDING

CLIENT:
MINISTRY OF HEALTH

LOCATION:
MULTIPLE ISLANDS

CONTENTS: AS GIVEN

PROJECT MANAGER:

DESIGNER: ARIZ

CIV/STR. ENGINEER:

SURVEYED BY: -

DRAWN BY: ARIZ

CHECKED BY:

DATE : DEC 2020


SHEET NO. : /



ADMIN DIVISION
Ministry of Health
Roshanae Building
Soan Nagar
Tel: 332 8887, Fax: 3328889


ELEVATION 'A'

SCALE: 1 : 100

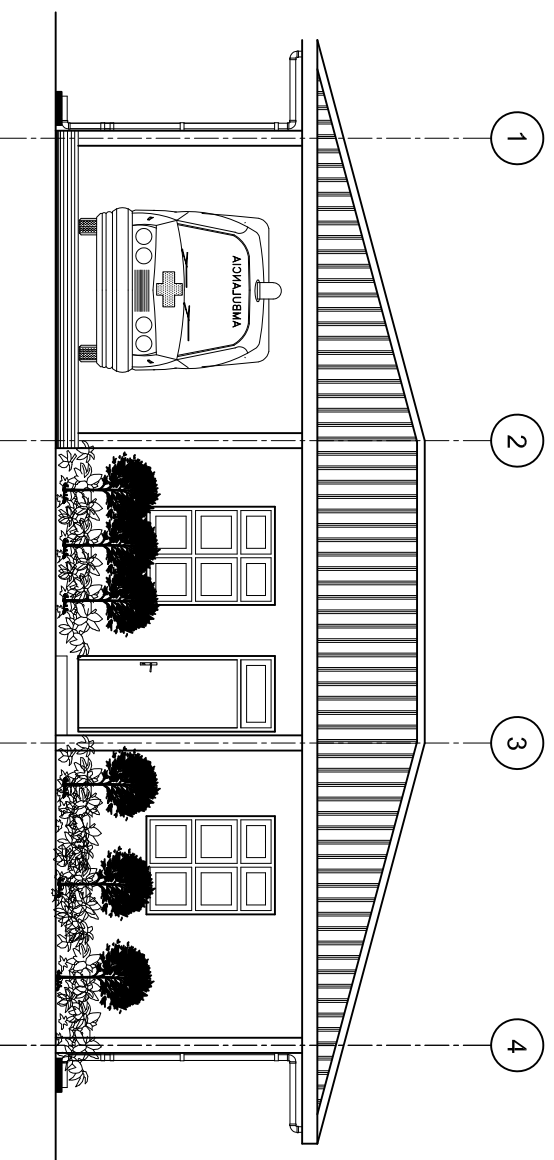

ELEVATION 'B'

SCALE: 1 : 100

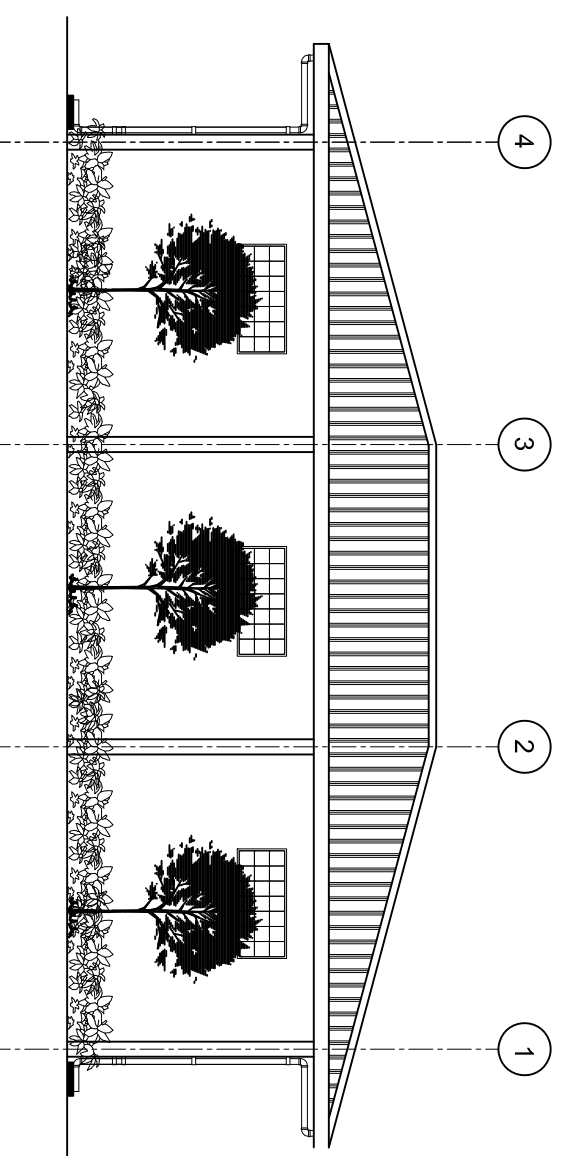

SHEET CONTENTS :

REVISION NOTES:

PROJECT:
CONSTRUCTION OF
SERVICES BUILDING

CLIENT:
MINISTRY OF HEALTH

LOCATION:
MULTIPLE ISLANDS

CONTENTS: AS GIVEN

PROJECT MANAGER:

DESIGNER: ARIZ

CIV/STR. ENGINEER:

SURVEYED BY: -

DRAWN BY: ARIZ

CHECKED BY:

DATE : DEC 2020

PAPER SIZE : A3


SHEET NO. : /



ADMIN DIVISION
Ministry of Health
Roshanae Building
Sasana Mega
Tel: 332 8887, Fax: 332 8889


ELEVATION 'D'

SCALE: 1 : 100

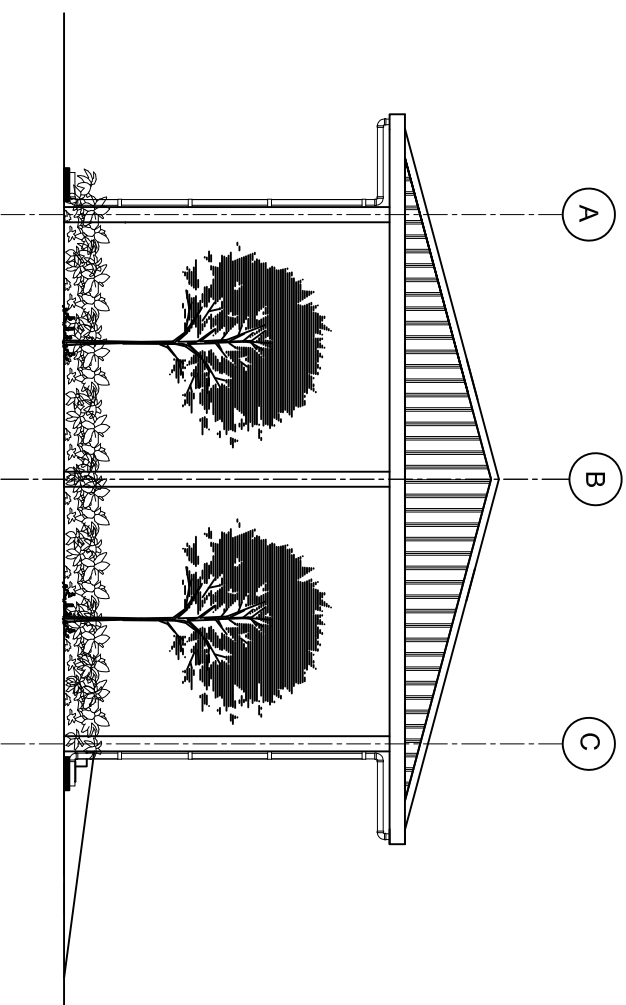

ELEVATION 'C'

SCALE: 1 : 100

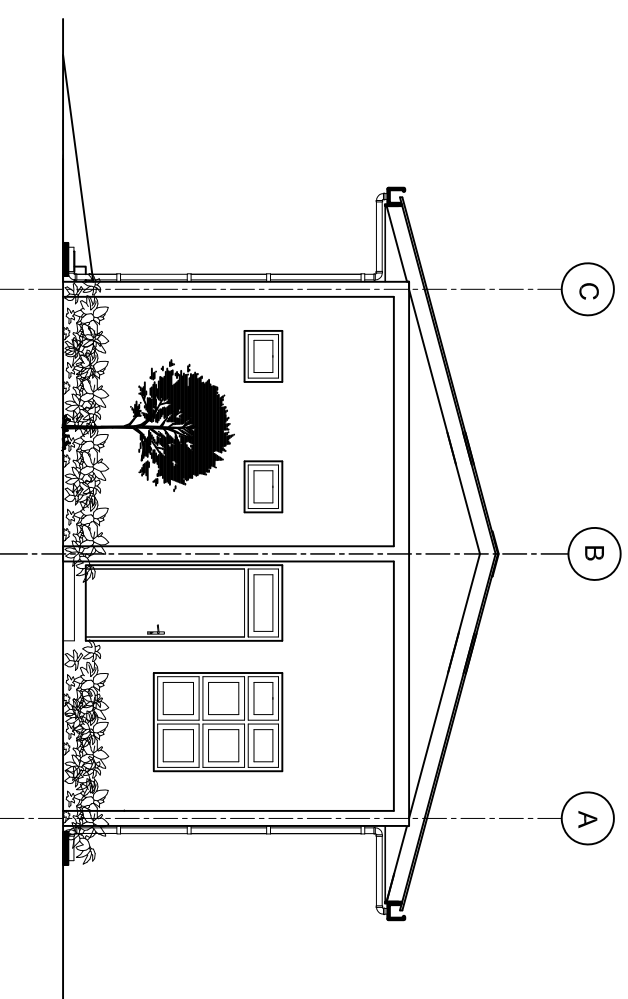

SHEET CONTENTS :

REVISION NOTES:

PROJECT:
CONSTRUCTION OF
SERVICES BUILDING

CLIENT:
MINISTRY OF HEALTH

LOCATION:
MULTIPLE ISLANDS

CONTENTS: AS GIVEN

PROJECT MANAGER:

DESIGNER: ARIZ

CIV/STR. ENGINEER:

SURVEYED BY: -

DRAWN BY: ARIZ

CHECKED BY:

DATE : DEC 2020


PAPER SIZE : A3

SHEET NO. : /



ROOF PLAN

SCALE: 1 : 100

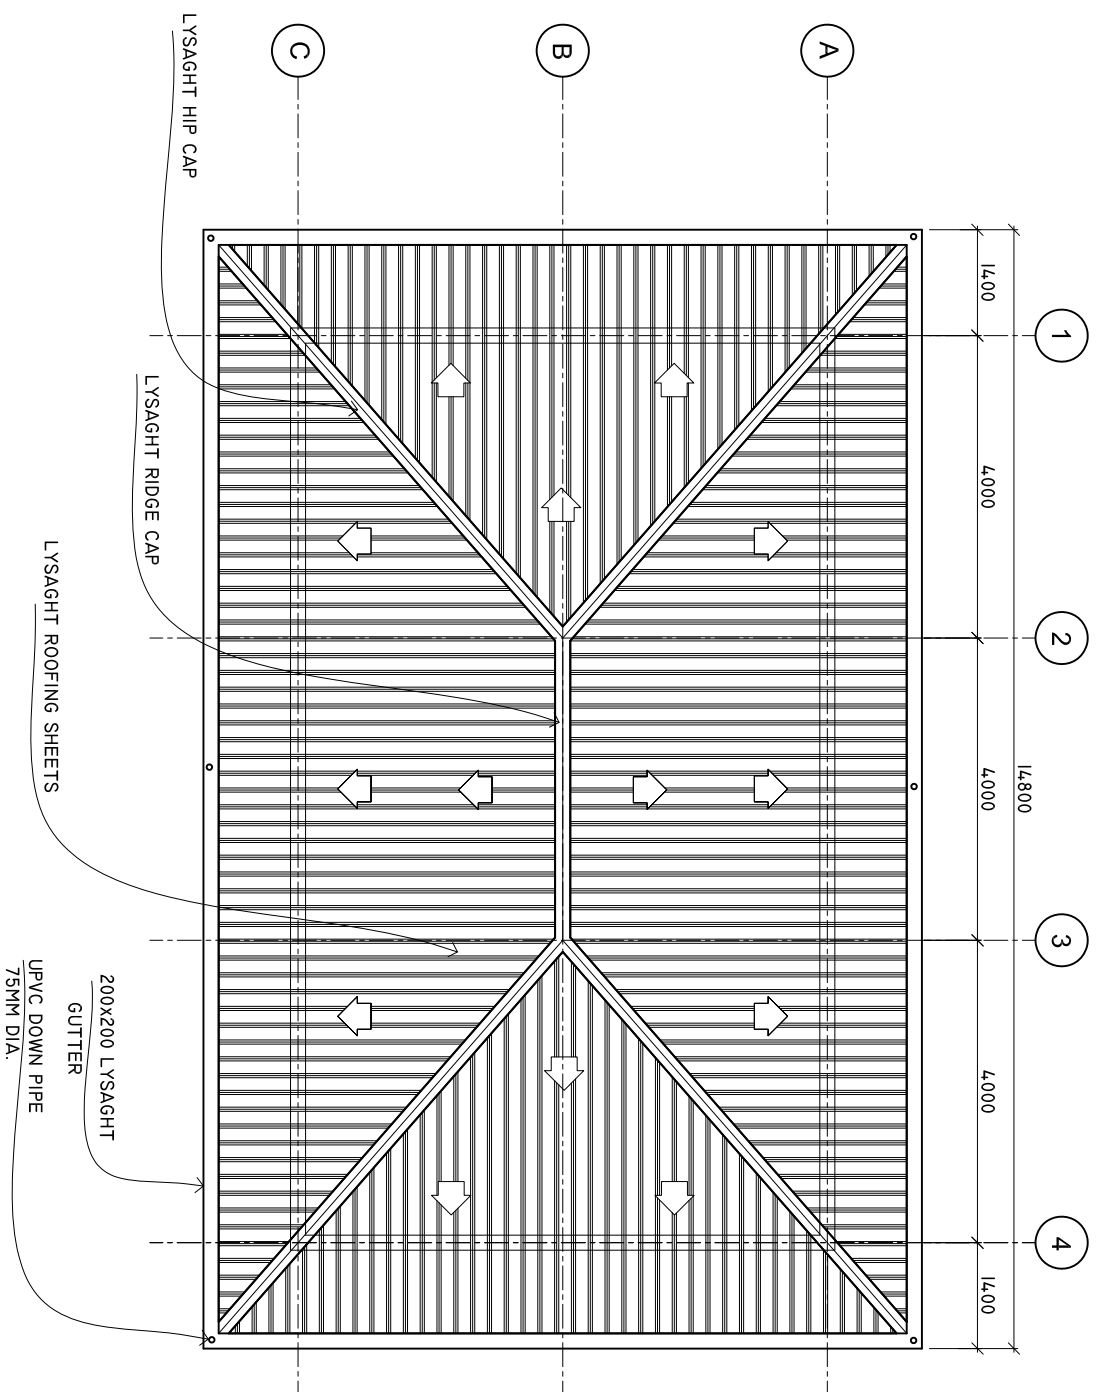

SHEET CONTENTS :

REVISION NOTES:

PROJECT:
CONSTRUCTION OF
SERVICES BUILDING

CLIENT:
MINISTRY OF HEALTH

LOCATION:
MULTIPLE ISLANDS

CONTENTS: AS GIVEN

PROJECT MANAGER:

DESIGNER: ARIZ

CIV/STR. ENGINEER:

SURVEYED BY: -

DRAWN BY: ARIZ

CHECKED BY:

DATE : DEC 2020


PAPER SIZE : A3

SHEET NO. : /



ROOF FRAMING PLAN

SCALE: 1 : 100

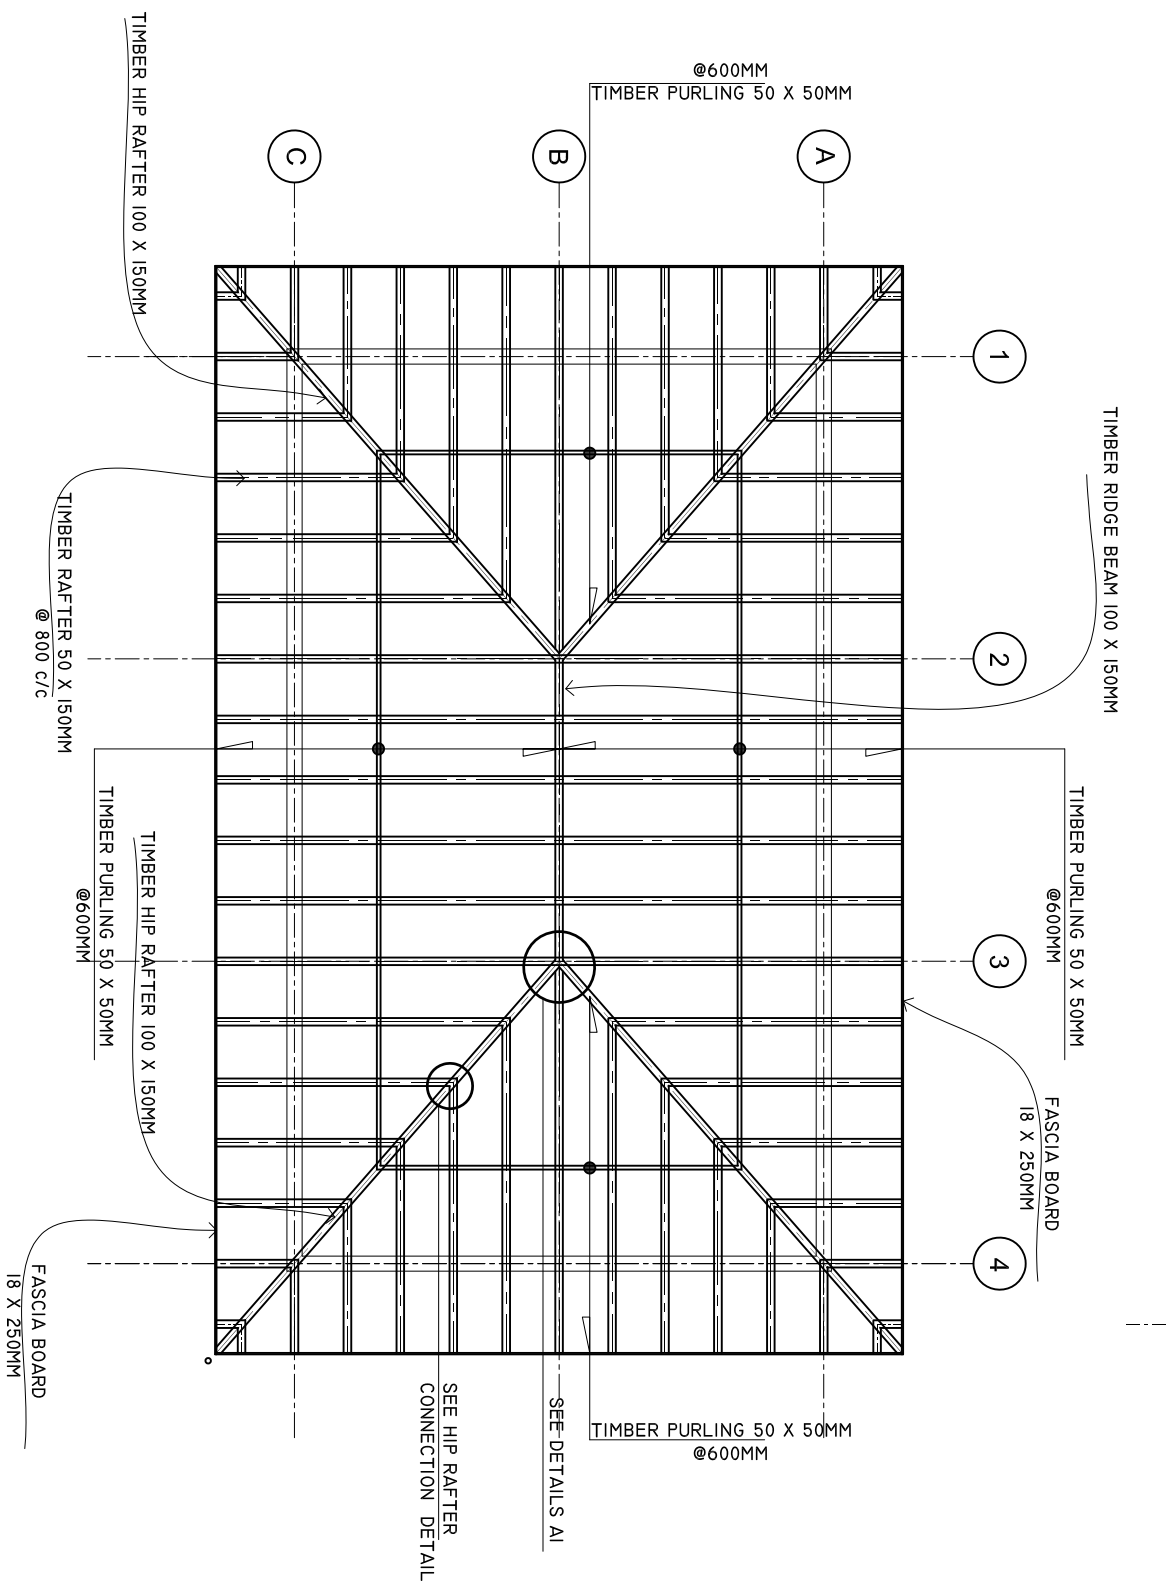

SHEET CONTENTS :

REVISION NOTES:

PROJECT:
CONSTRUCTION OF
SERVICES BUILDING

CLIENT:
MINISTRY OF HEALTH

LOCATION:
MULTIPLE ISLANDS

CONTENTS: AS GIVEN

PROJECT MANAGER:

DESIGNER: ARIZ

CIV/STR. ENGINEER:

SURVEYED BY: -

DRAWN BY: ARIZ

CHECKED BY:

DATE : DEC 2020






PAPER SIZE : A3



SHEET NO. : /



DOORS AND WINDOWS SCHEDULE

Scale 1:50

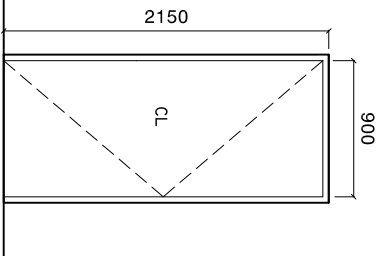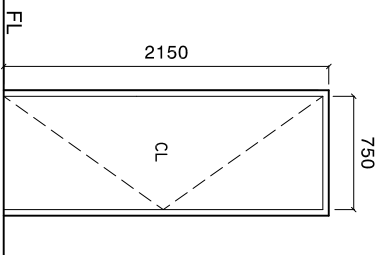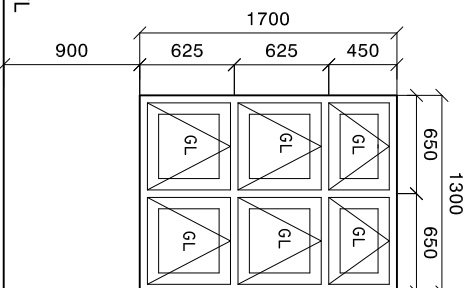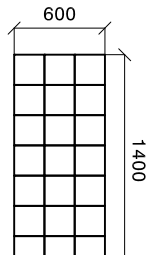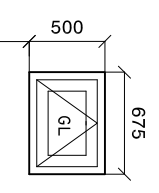SYMBOL	D1	D2	W1	W2	V1
ELEVATION					
LOCATION	GROUND FLOOR	GROUND FLOOR	GROUND FLOOR	GROUND FLOOR	GROUND FLOOR
DESCRIPTION	40MM THICK OPENABLE ALUMINIUM FRAMED DOOR	40MM THICK OPENABLE ALUMINIUM FRAMED DOOR	ALUMINIUM FRAMED OPENABLE DOOR PANEL	200X200MM GLASS BLOCK	ALUMINIUM FRAMED OPENABLE DOOR PANEL
FRAME	120MM ALUMINIUM FRAME 80 MICRON WHITE POWDER COATED	120MM ALUMINIUM FRAME 80 MICRON WHITE POWDER COATED	120MM ALUMINIUM FRAME 80 MICRON WHITE POWDER COATED		120MM ALUMINIUM FRAME 80 MICRON WHITE POWDER COATED
HARDWARE	DOOR CLOSER HANDLE LOCK BUTT HINGE STOPPER HOLDER KICKER	DOOR CLOSER HANDLE LOCK BUTT HINGE STOPPER HOLDER KICKER	OPENABLE FRAME HANDLE LOCK		OPENABLE FRAME HANDLE LOCK
GLAZING	C-6MM ALL FIXED PANELS TO BE DOUBLE GLASSED	C-6MM ALL FIXED PANELS TO BE DOUBLE GLASSED	6MM THICK HEAT REFLECTIVE GLASS		6MM THICK HEAT REFLECTIVE GLASS
NOTE	ALL MEASUREMENTS TO BE CHECKED ON SITE	ALL MEASUREMENTS TO BE CHECKED ON SITE	ALL MEASUREMENTS TO BE CHECKED ON SITE	ALL MEASUREMENTS TO BE CHECKED ON SITE	ALL MEASUREMENTS TO BE CHECKED ON SITE

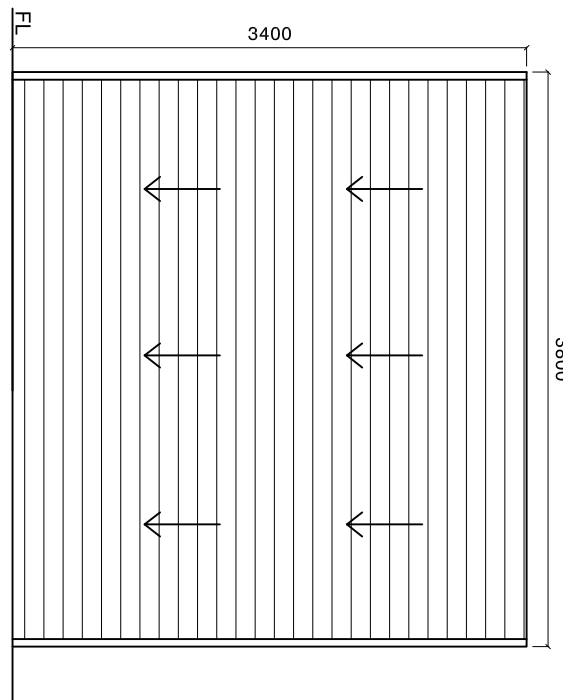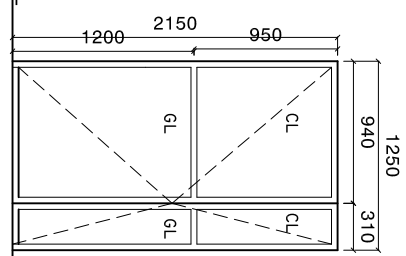SYMBOL	D3	D4
ELEVATION		
LOCATION	GROUND FLOOR	GROUND FLOOR
DESCRIPTION	ROLLER SHUTTER DOOR	40MM THICK OPENABLE ALUMINIUM FRAMED DOOR
FRAME	80 MICRON WHITE POWDER COATED	120MM ALUMINIUM FRAME 80 MICRON WHITE POWDER COATED
HARDWARE	LOCK	DOOR CLOSER HANDLE LOCK BUTT HINGE STOPPER HOLDER KICKER
GLAZING	C-6MM ALL FIXED PANELS TO BE DOUBLE GLASSED	C-6MM ALL FIXED PANELS TO BE DOUBLE GLASSED
NOTE	ALL MEASUREMENTS TO BE CHECKED ON SITE	ALL MEASUREMENTS TO BE CHECKED ON SITE

NOTE:

PROVIDE RC LINTEL ABOVE ALL DOOR/WINDOW/VENTILATOR UNITS NOT FIXED TO BEAMS
AND PROVIDE RC SILL BEAMS UNDER ALL WINDOW UNITS
ALL TIMBER DOORS TO BE MADE OF TIMBER, PUTTY SMOOTHED AND FINISHED WITH ENAMEL PAINT AS SPECIFIED

GL= 6MM TICK TINTED LAMINATED GLASS
CL= 4MM TICK POWDER COATED CLADDING SHEET

ALL THE ALUMINIUM PROFILE MUST BE MINIMUM 2MM THICK.

SHEET CONTENTS :

REVISION NOTES:

PROJECT:
CONSTRUCTION OF
SERVICE BUILDING

CLIENT:
MINISTRY OF HEALTH

LOCATION:
MULTIPLE ISLANDS

CONTENTS: AS GIVEN

PROJECT MANAGER:

DESIGNER: ARIZ

CV/STR. ENGINEER:

SURVEYED BY: -

DRAWN BY: ARIZ

CHECKED BY:

DATE : JAN 2020


SHEET NO. : /



ADMIN DIVISION
Ministry of Health
Residence Building
Soan Mlage
Tel: 332 8887, Fax: 332 8889

ELECTRICAL LAYOUT

SCALE: 1 : 100

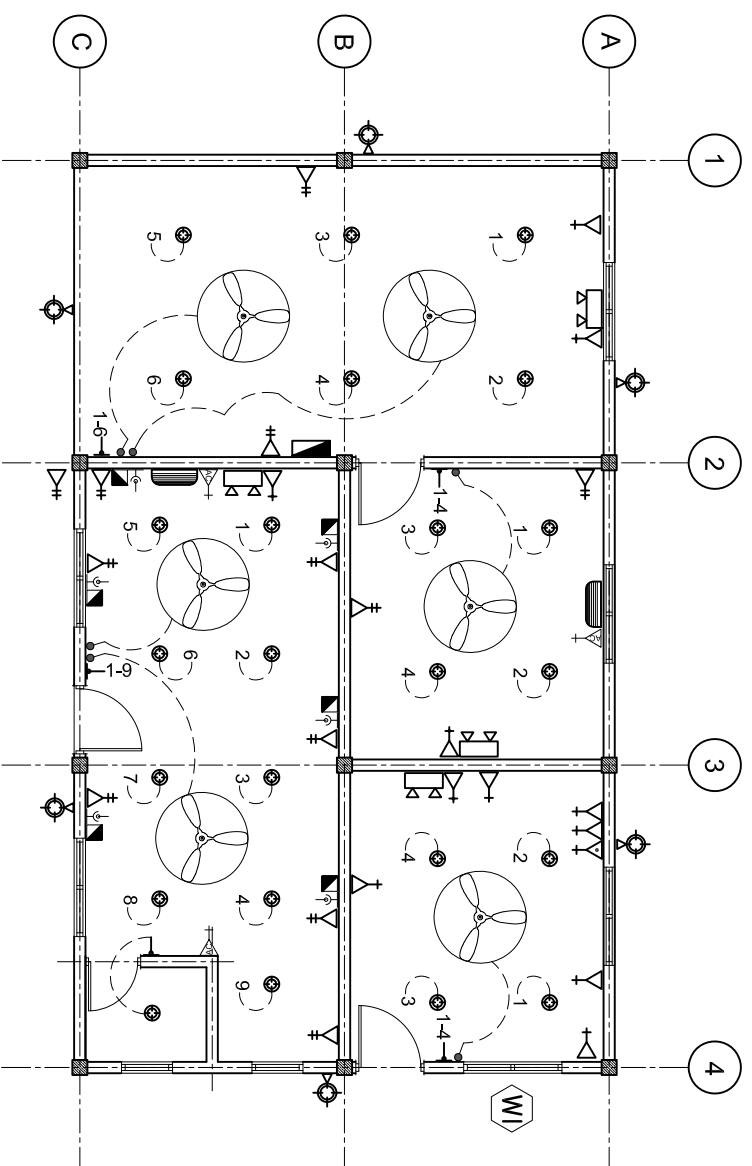

LEGEND

SYMBOL	DESCRIPTION
	LED BULB WITH 200MM DOWN LIGHT
	1 x 13 AMP SOCKET OUTLET (1200MM ABOVE FFL)
	2 x 13 AMP SOCKET OUTLET (300MM ABOVE FFL)
	1 x 15 AMP SOCKET OUTLET (1200MM ABOVE FFL)
	1 x 13 AMP SOCKET OUTLET (200MM BELOW CEILING)
	1 x 15 AMP AC SOCKET OUTLET (ABOVE THE CEILING)
	TWO GANG SWITCH
	ONE WAY SWITCH
	EMERGENCY LIGHT
	DISTRIBUTION BOARD (WALL EMBEDDED)
	OUTDOOR LIGHT
	CEILING FAN 1200MM DIA.
	FAN REGULATOR
	TELEPHONE SOCKET
	NETWORK SOCKET
	AC WALL MOUNT UNIT

SHEET CONTENTS :

REVISION NOTES:

PROJECT:
CONSTRUCTION OF
SERVICE BUILDING

CLIENT:
MINISTRY OF HEALTH

LOCATION:
MULTIPLE ISLANDS

CONTENTS: AS GIVEN

PROJECT MANAGER:

DESIGNER: ARIZ

CIV/STR. ENGINEER:

SURVEYED BY: -

DRAWN BY: ARIZ

CHECKED BY:


DATE : DEC 2020

SHEET NO. : /



COLUMN LAYOUT

SCALE: 1 : 100

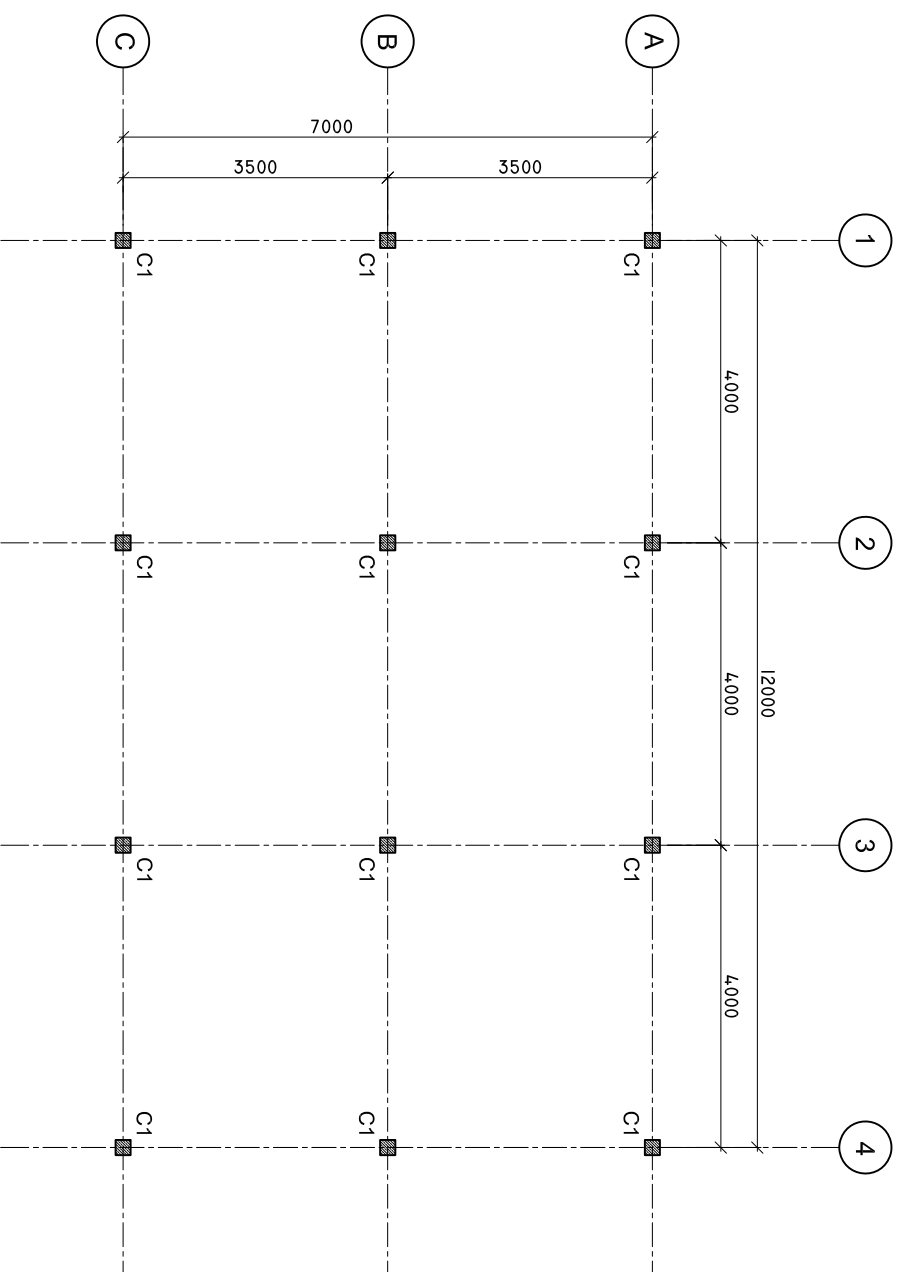

SHEET CONTENTS :

REVISION NOTES:

PROJECT:
CONSTRUCTION OF
SERVICES BUILDING

CLIENT:

MINISTRY OF HEALTH

LOCATION:
MULTIPLE ISLANDS

CONTENTS: AS GIVEN

PROJECT MANAGER:

DESIGNER: ARIZ

CIV/STR. ENGINEER:

SURVEYED BY: -

DRAWN BY: ARIZ

CHECKED BY:

DATE : DEC 2020


PAPER SIZE : A3

SHEET NO. : /



TIE BEAM PLAN

SCALE: 1 : 100

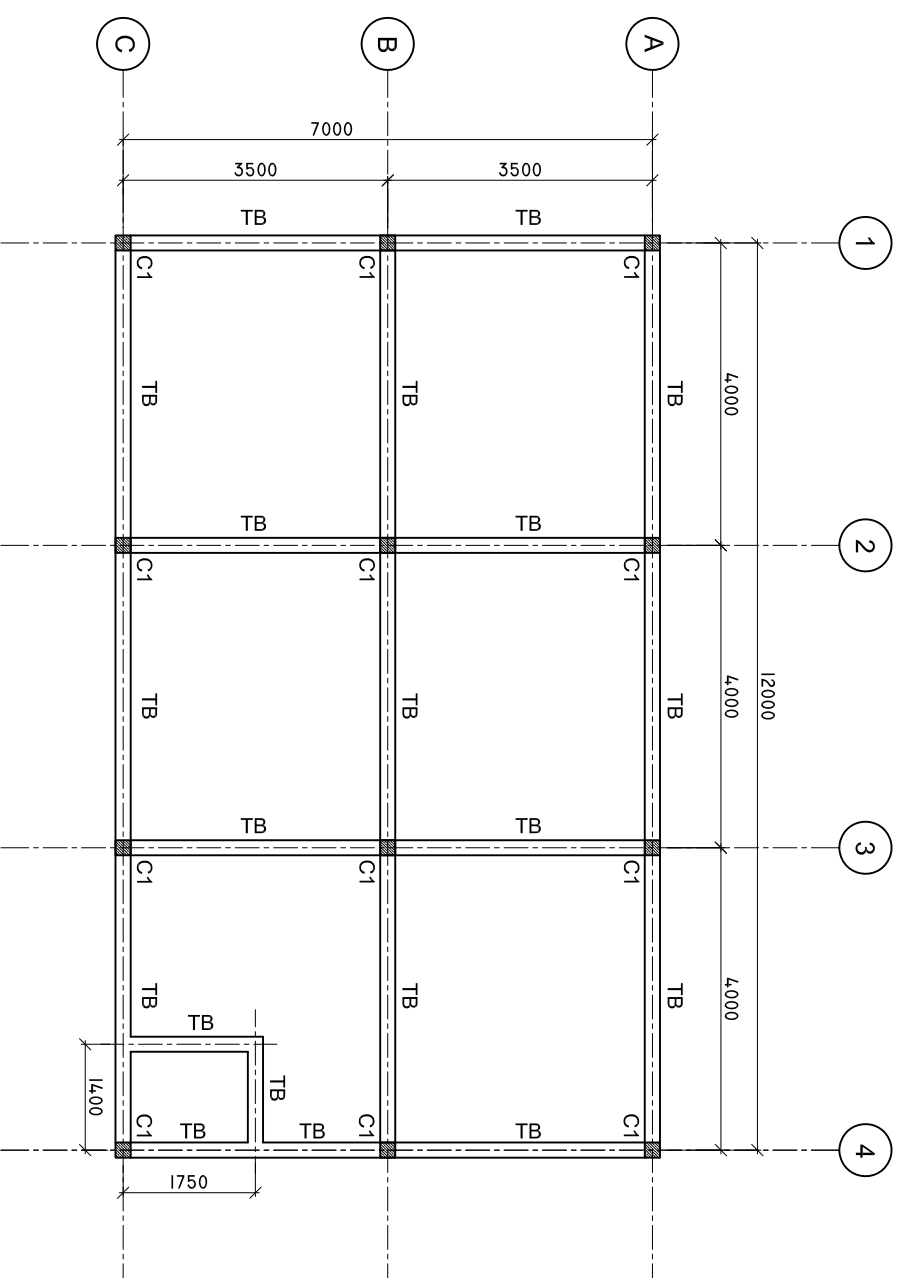

SHEET CONTENTS :

REVISION NOTES:

PROJECT:
CONSTRUCTION OF
SERVICES BUILDING

CLIENT:
MINISTRY OF HEALTH

LOCATION:
MULTIPLE ISLANDS

CONTENTS: AS GIVEN

PROJECT MANAGER:

DESIGNER: ARIZ

CIV/STR. ENGINEER:

SURVEYED BY: -

DRAWN BY: ARIZ

CHECKED BY:

DATE : DEC 2020

PAPER SIZE : A3


SHEET NO. : /



ADMIN DIVISION
Ministry of Health
Roshanae Building
Soana Maqat
Tel: 332 8887, Fax: 332 8889

ROOF BEAM PLAN

SCALE: 1 : 100

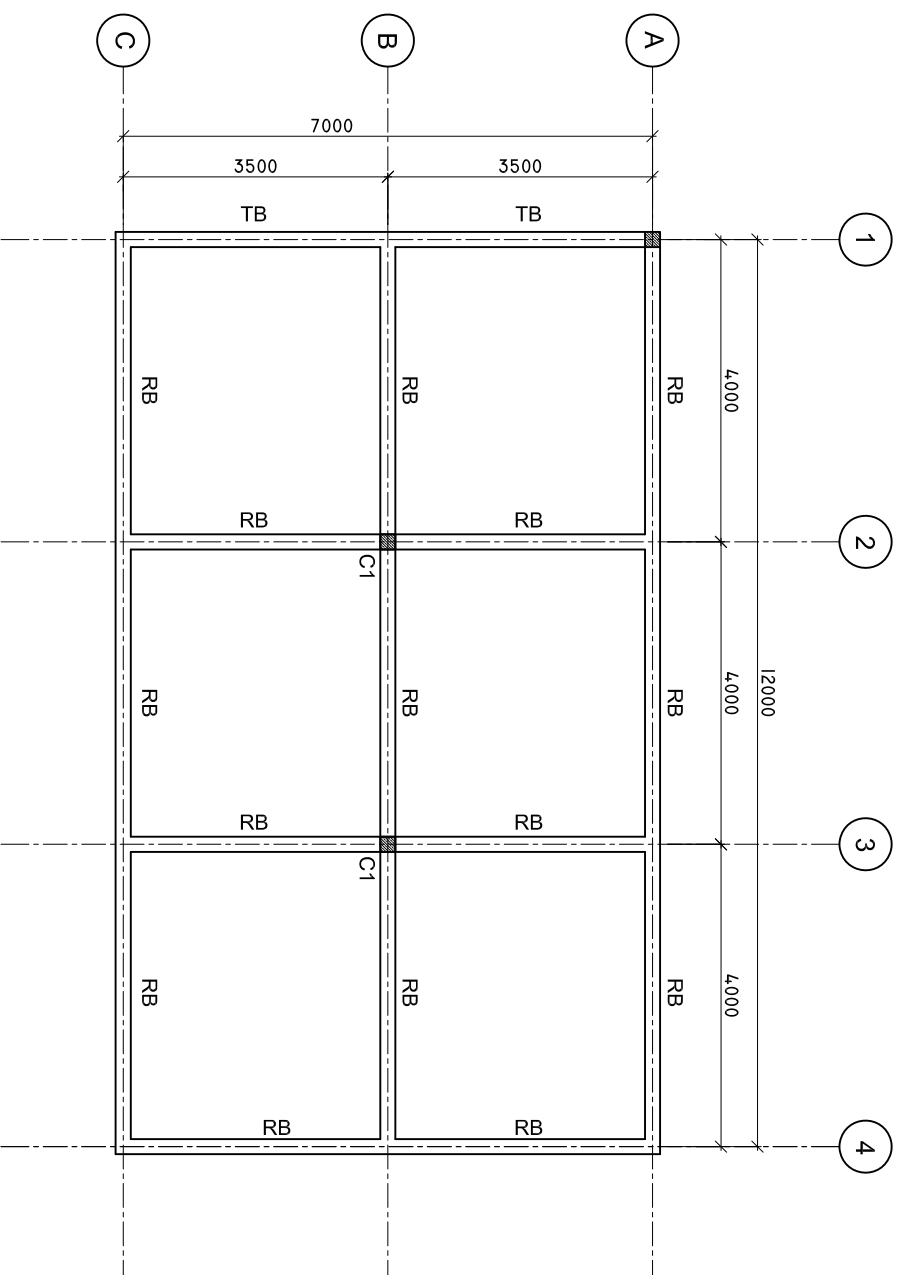

SHEET CONTENTS :

REVISION NOTES:

PROJECT:
CONSTRUCTION OF
SERVICES BUILDING

CLIENT:
MINISTRY OF HEALTH

LOCATION:
MULTIPLE ISLANDS

CONTENTS: AS GIVEN

PROJECT MANAGER:

DESIGNER: ARIZ

CIV/STR. ENGINEER:

SURVEYED BY: -

DRAWN BY: ARIZ

CHECKED BY:

DATE : DEC 2020

PAPER SIZE : A3


SHEET NO. : /




ADMIN DIVISION
Ministry of Health
Rosharaa Building
Soana Maaga
Tel: 332 8887, Fax: 332 8889

DETAILS R/C


SCALE: 1 : 25

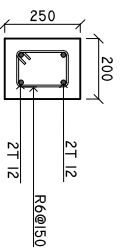


TIE BEAM (TB)

 


COLUMN (C1)

 

ROOF BEAM (RB)

 

LINTEL BEAM

 

SILL BEAM

MINIMUM 50MM COVER BELOW GROUND LEVEL	ALL BAR BENDING & OVERLAPS AS PER ACTUAL BS STANDARD.
MINIMUM 30MM COVER ABOVE GROUND LEVEL	

NOTE:
LINTEL BEAMS TO BE LAID ABOVE AND BELOW ALL WINDOWS AND ALL DOORS.

SHEET CONTENTS :

REVISION NOTES:

PROJECT:
CONSTRUCTION OF SERVICES BUILDING

CLIENT:

MINISTRY OF HEALTH

LOCATION:
MULTIPLE ISLANDS

CONTENTS: AS GIVEN

PROJECT MANAGER:

DESIGNER: ARIZ

CIV/STR. ENGINEER:

SURVEYED BY: -

DRAWN BY: ARIZ

CHECKED BY:

DATE : DEC 2020


PAPER SIZE : A3

SHEET NO. : /



CROSS SECTION X-X

SCALE: 1 : 50

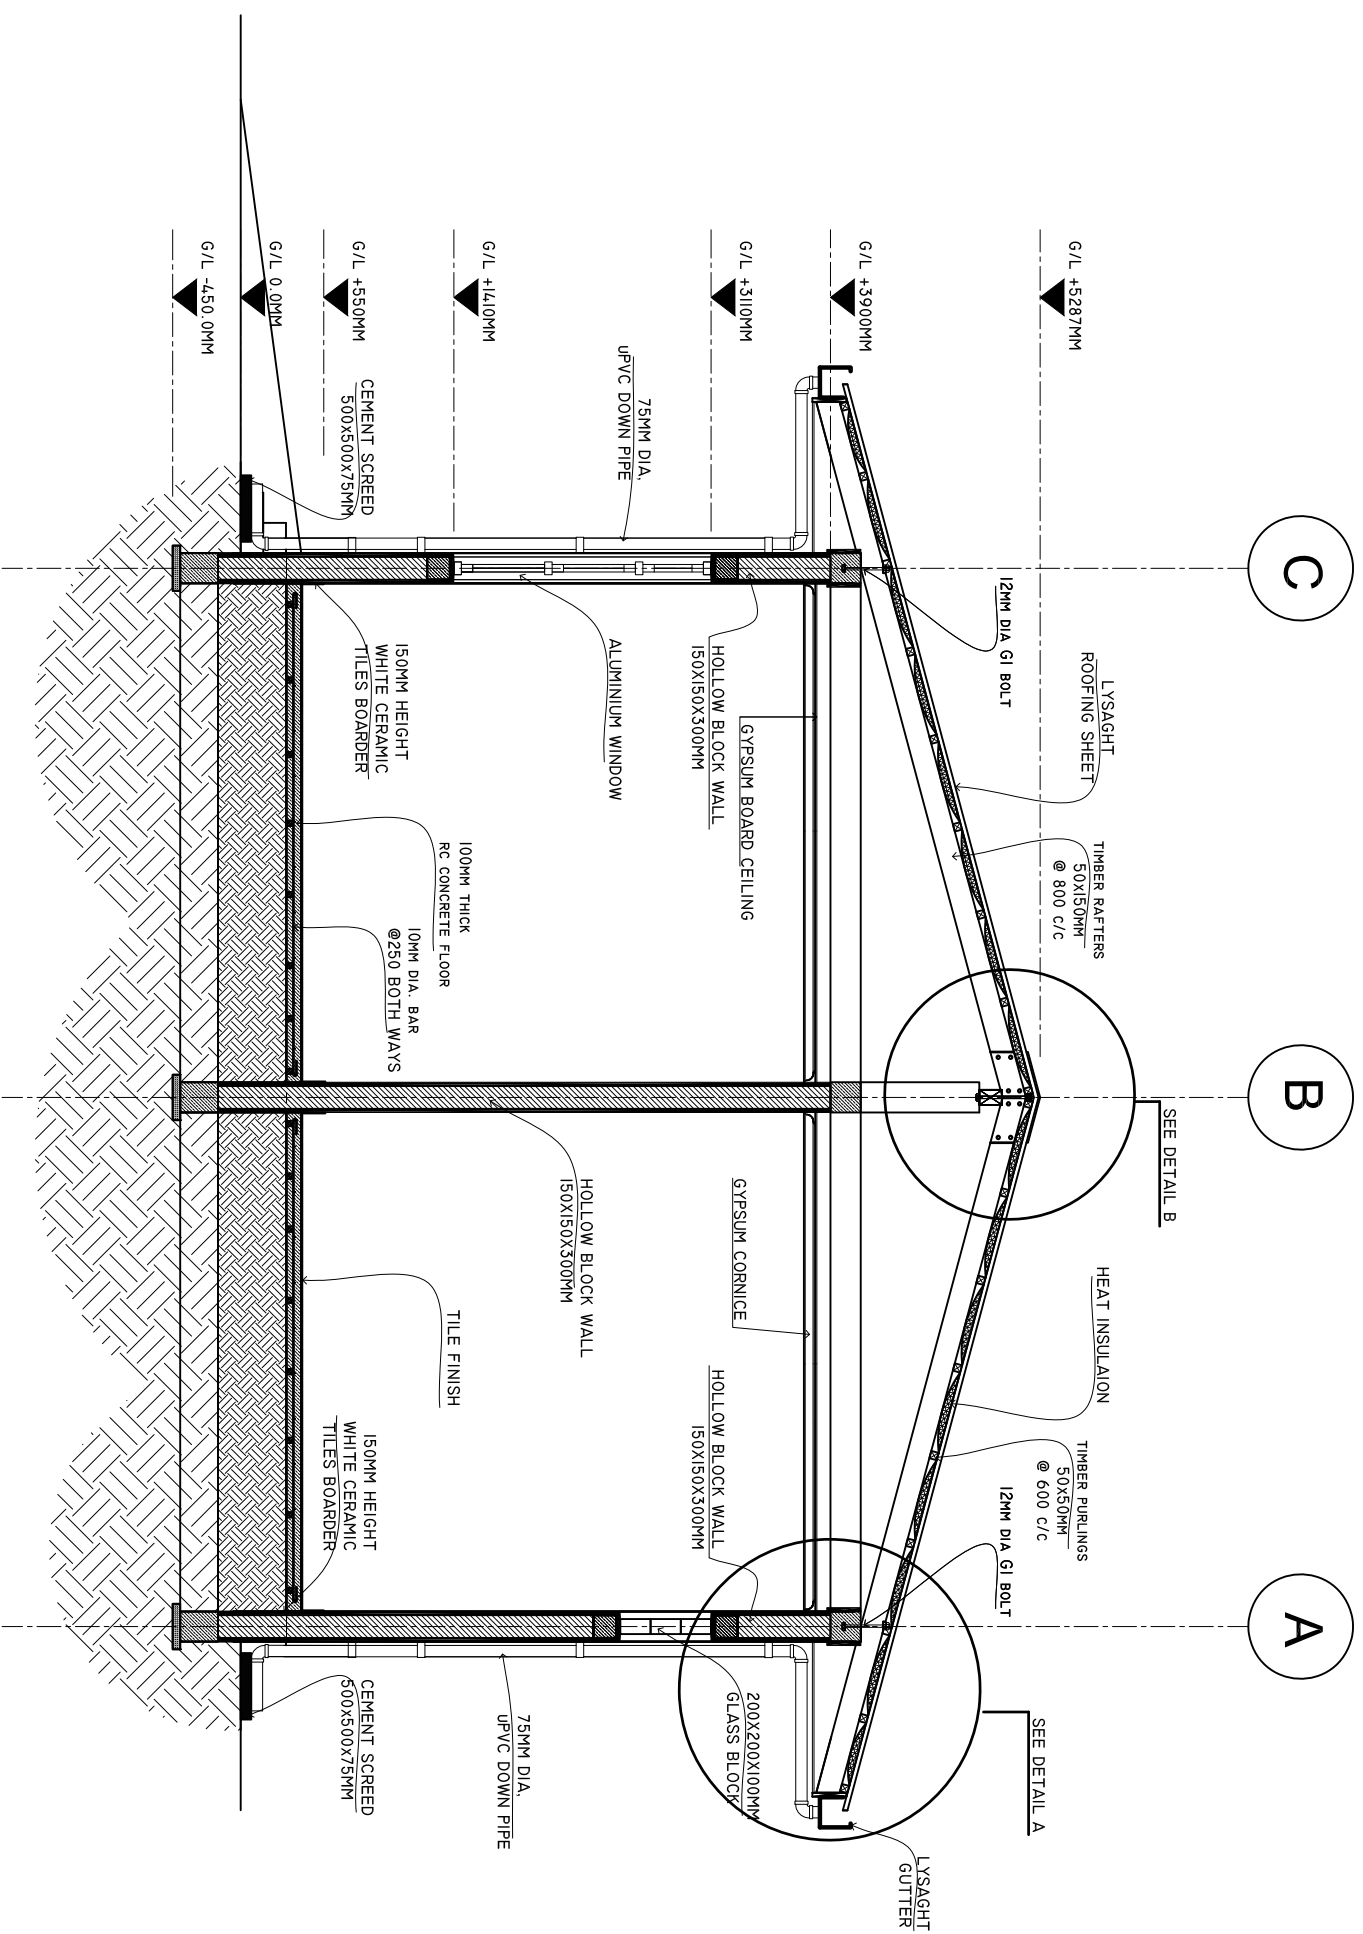

SHEET CONTENTS :

REVISION NOTES:

PROJECT:
CONSTRUCTION OF
SERVICES BUILDING

CLIENT:
MINISTRY OF HEALTH

LOCATION:
MULTIPLE ISLANDS

CONTENTS: AS GIVEN

PROJECT MANAGER:

DESIGNER: ARIZ

CIV/STR. ENGINEER:

SURVEYED BY: -

DRAWN BY: ARIZ

CHECKED BY:

DATE : DEC 2020


PAPER SIZE : A3

SHEET NO. : /



DETAIL A

SCALE: 1 : 10

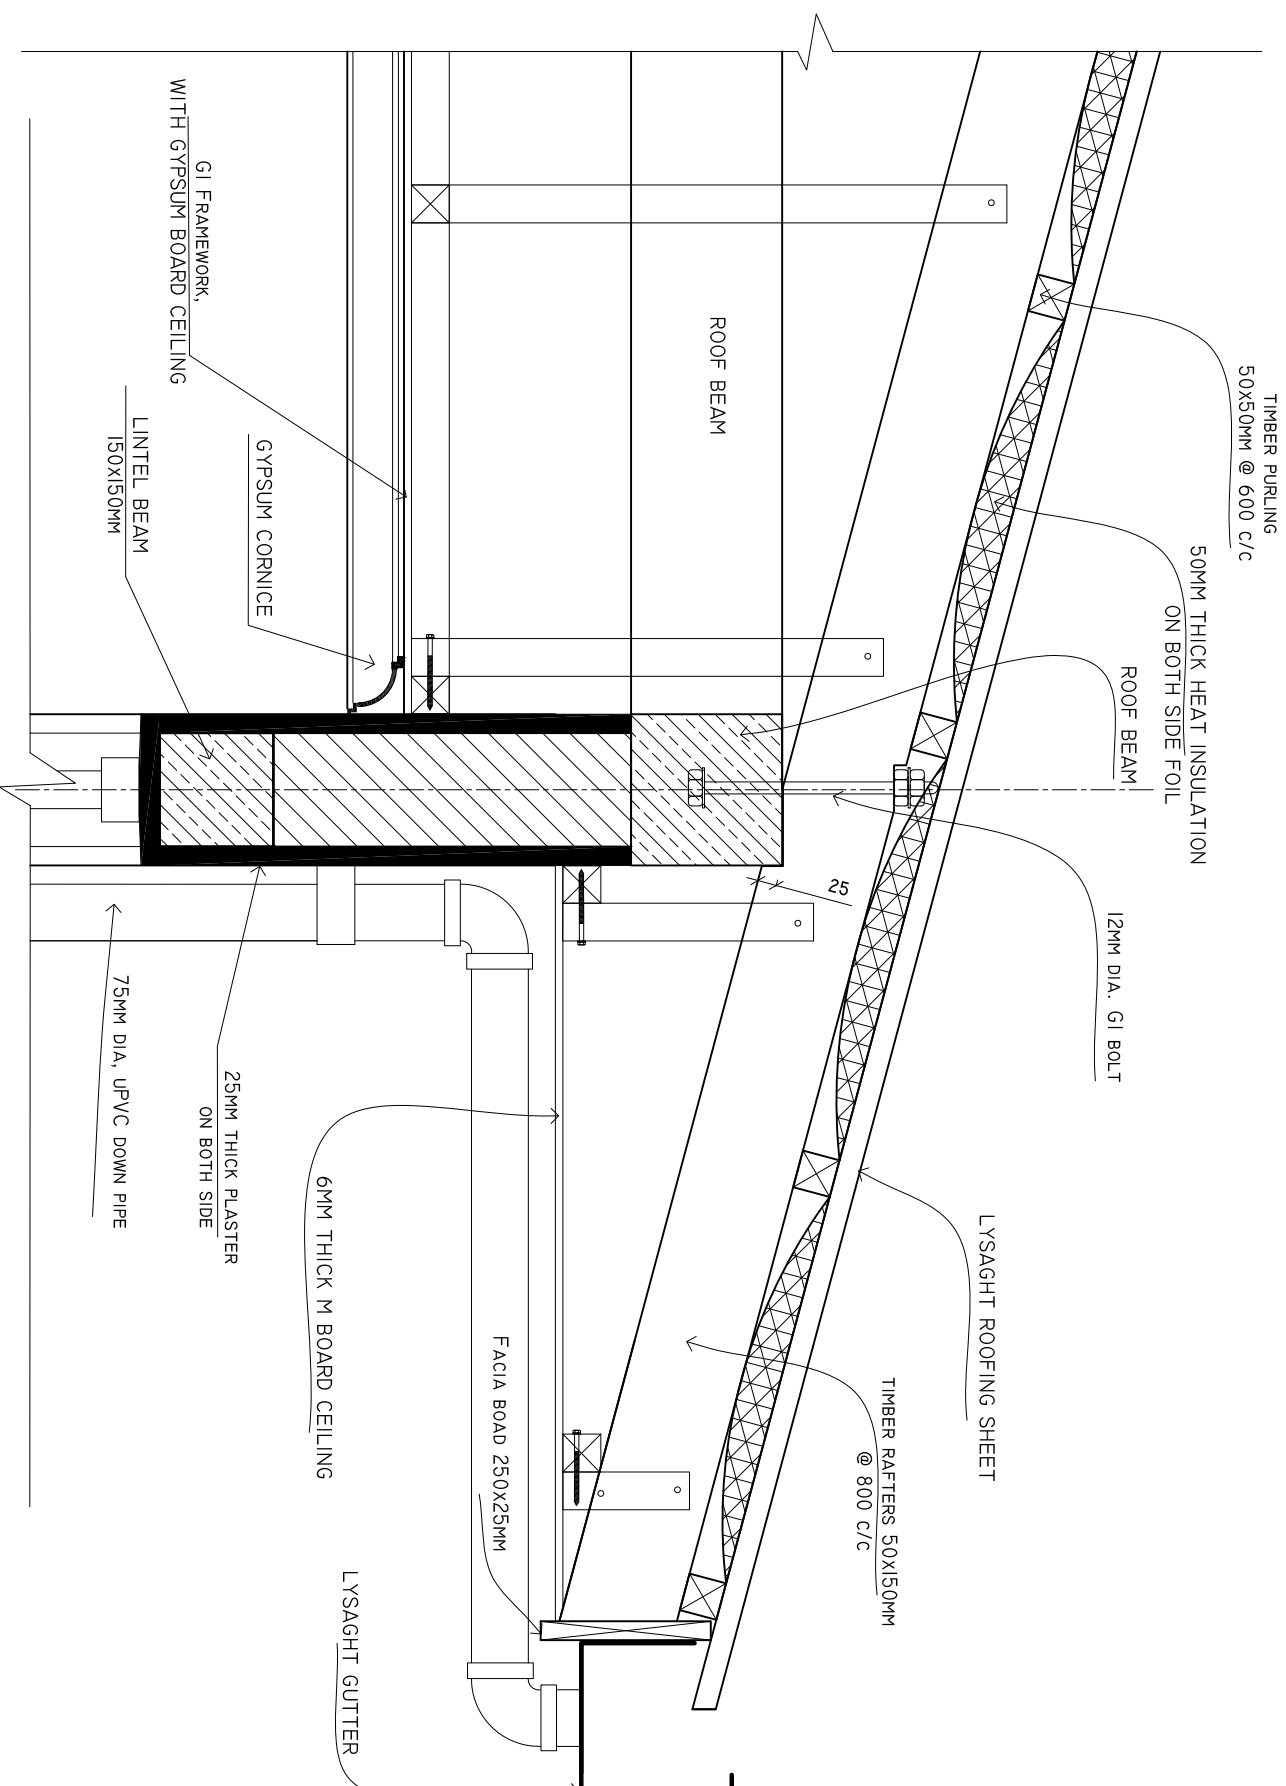

SHEET CONTENTS :

REVISION NOTES:

PROJECT:
CONSTRUCTION OF
SERVICES BUILDING

CLIENT:
MINISTRY OF HEALTH

LOCATION:
MULTIPLE ISLANDS


CONTENTS: AS GIVEN

PROJECT MANAGER:
DESIGNER: ARIZ
CIV/STR. ENGINEER:
SURVEYED BY: -
DRAWN BY: ARIZ
CHECKED BY:
DATE : DEC 2020
PAPER SIZE : A3
SHEET NO. : /



DETAIL B

SCALE: 1 : 10

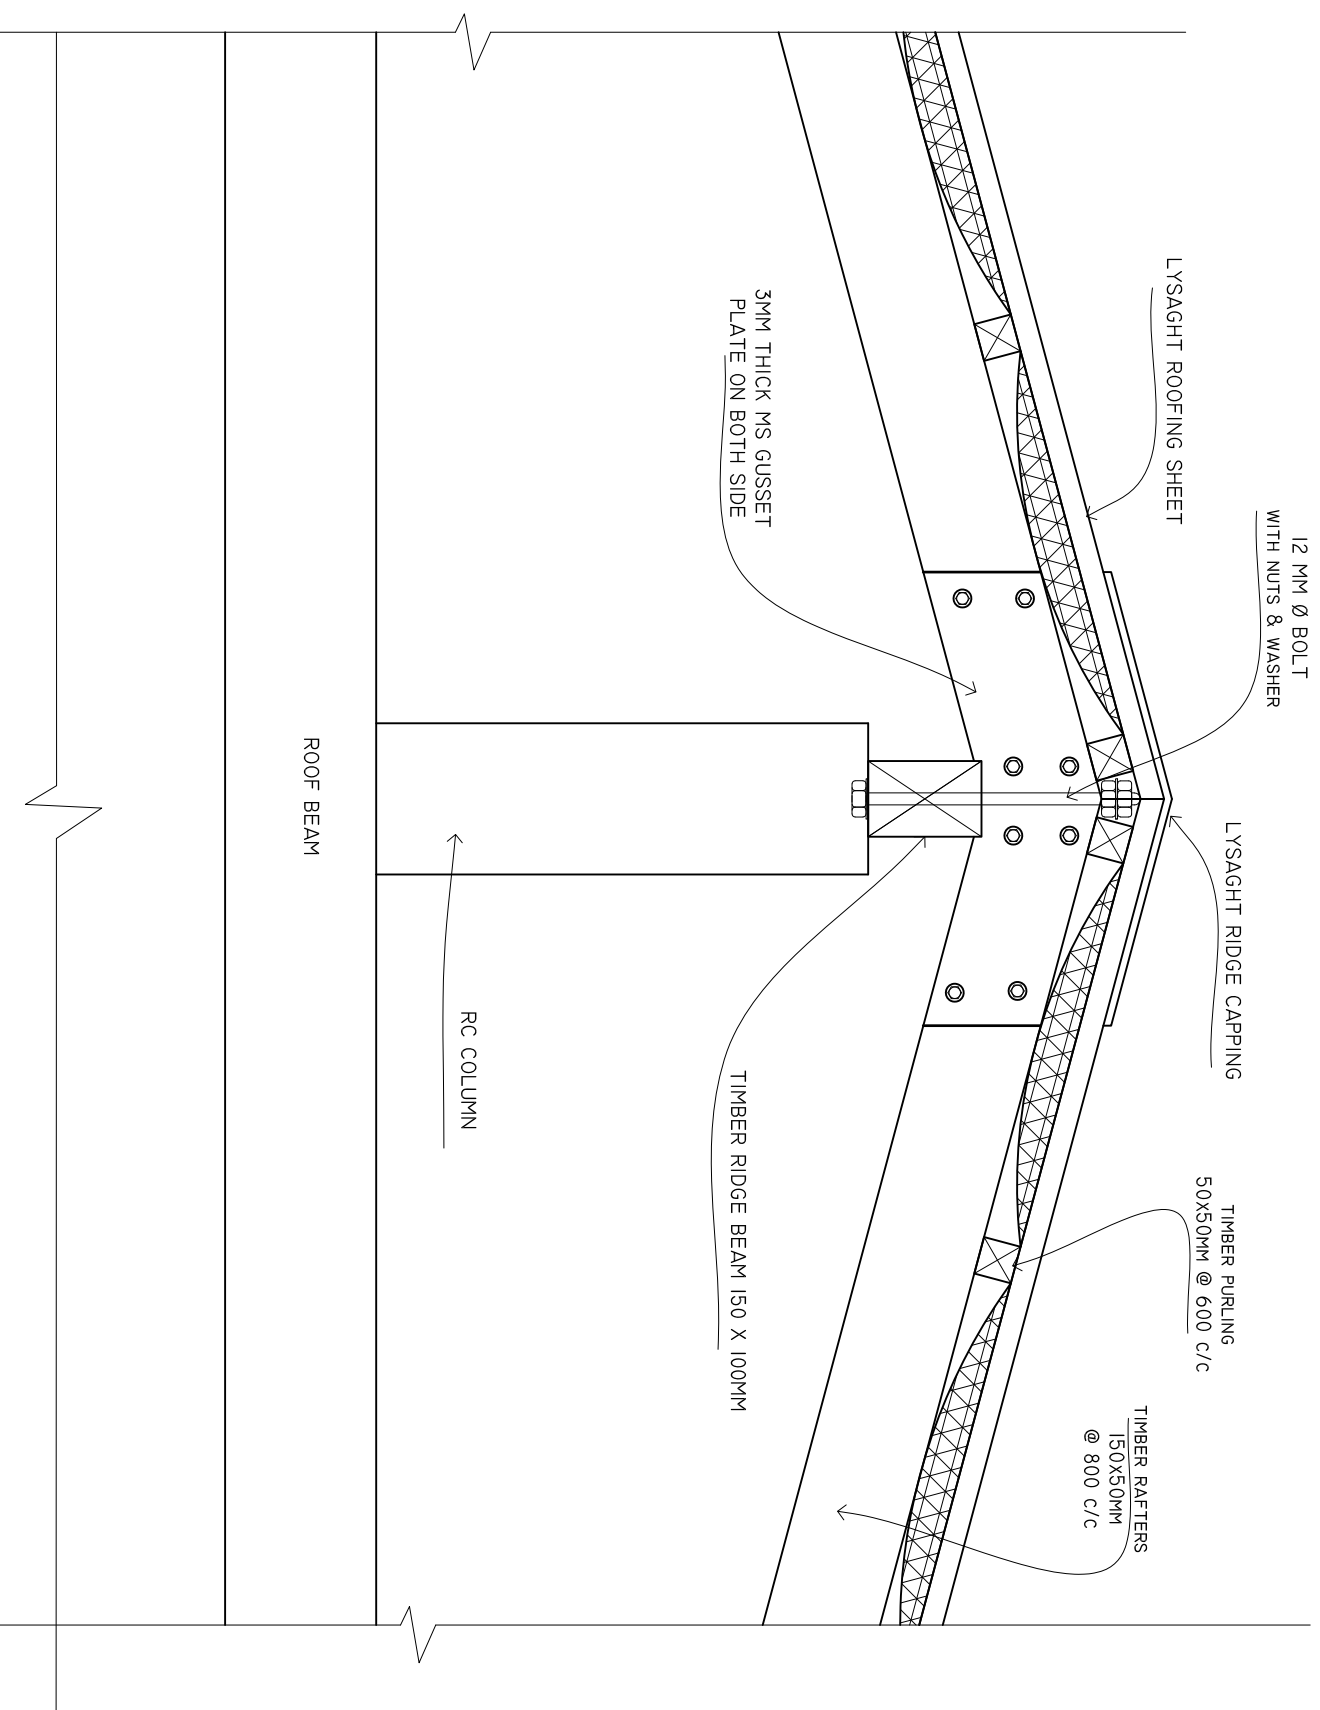

SHEET CONTENTS :

REVISION NOTES:

PROJECT:
CONSTRUCTION OF
SERVICES BUILDING

CLIENT:
MINISTRY OF HEALTH

LOCATION:
MULTIPLE ISLANDS

CONTENTS: AS GIVEN

PROJECT MANAGER:

DESIGNER: ARIZ

CIV/STR. ENGINEER:

SURVEYED BY: -

DRAWN BY: ARIZ

CHECKED BY:

DATE : DEC 2020

PAPER SIZE : A3


SHEET NO. : /



ADMIN DIVISION
Ministry of Health
Roshanae Building
Soana Maaga
Tel: 332 8887, Fax: 332 8889


HIP RAFTER CONNECTION DETAIL

SCALE: 1 : 10

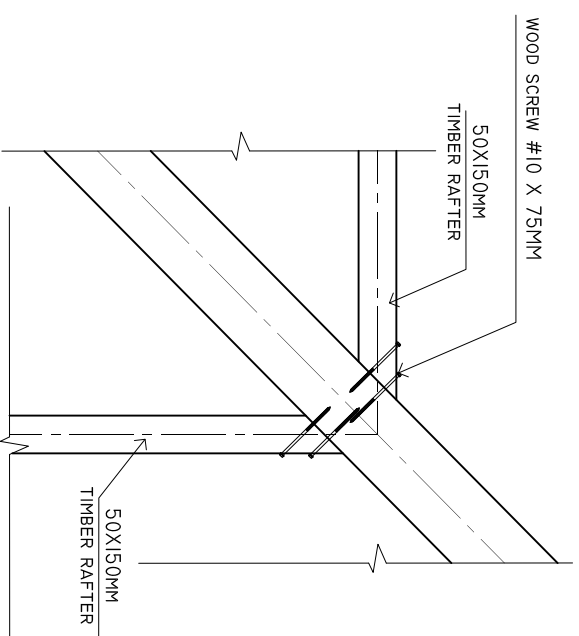

DETAILS A1

SCALE: 1 : 10

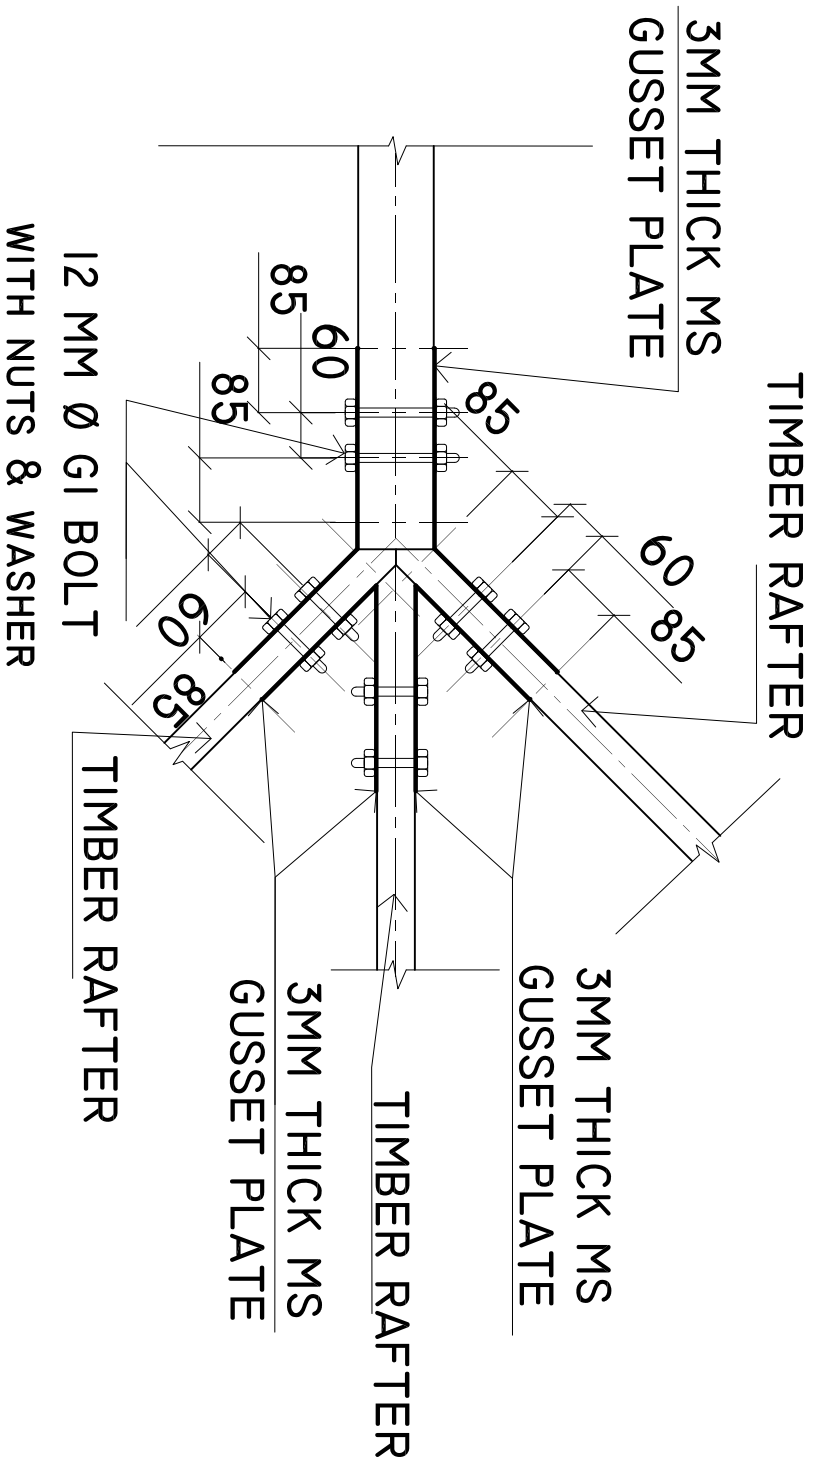

SHEET CONTENTS :

REVISION NOTES:

PROJECT:
CONSTRUCTION OF
SERVICES BUILDING

CLIENT:
MINISTRY OF HEALTH

LOCATION:
MULTIPLE ISLANDS


CONTENTS: AS GIVEN

PROJECT MANAGER:
DESIGNER: ARIZ
CIV/STR. ENGINEER:
SURVEYED BY: -
DRAWN BY: ARIZ
CHECKED BY:
DATE : DEC 2020
PAPER SIZE : A3
SHEET NO. : /



SINK CUPBOARD PLAN


SCALE: 1 : 20

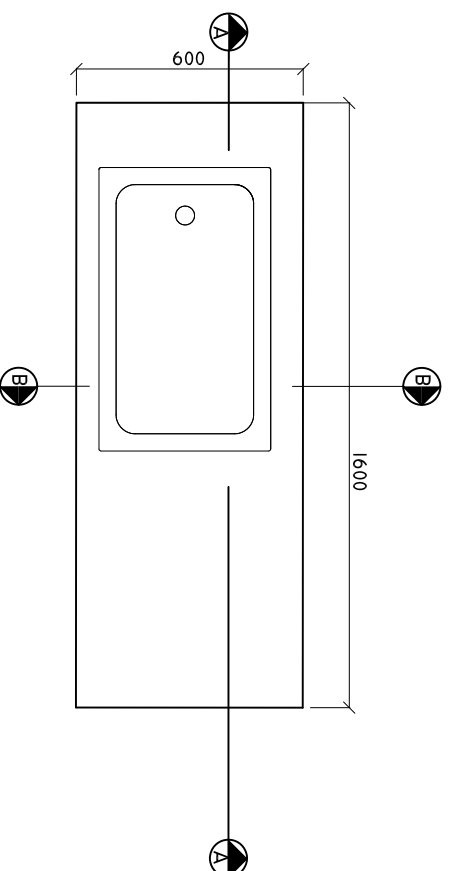

NOTE: PLEASE CHECK ALL MEASUREMENTS ON SITE BEFORE CARRYING OUT WORK

SINK CUPBOARD ELEVATION


SCALE: 1 : 20

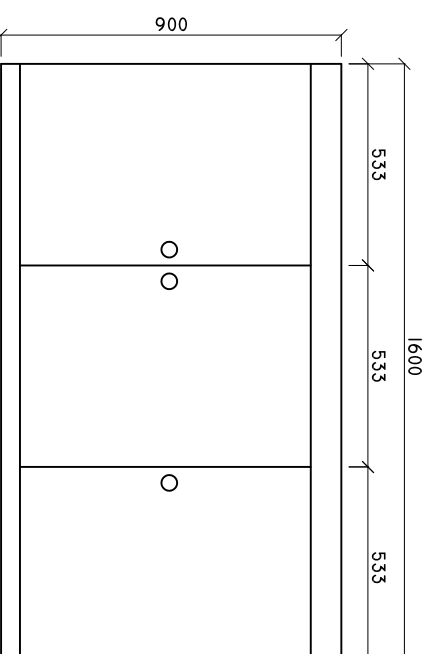

NOTE: PLEASE CHECK ALL MEASUREMENTS ON SITE BEFORE CARRYING OUT WORK

SINK CUPBOARD DETAIL B-B


SCALE: 1 : 20

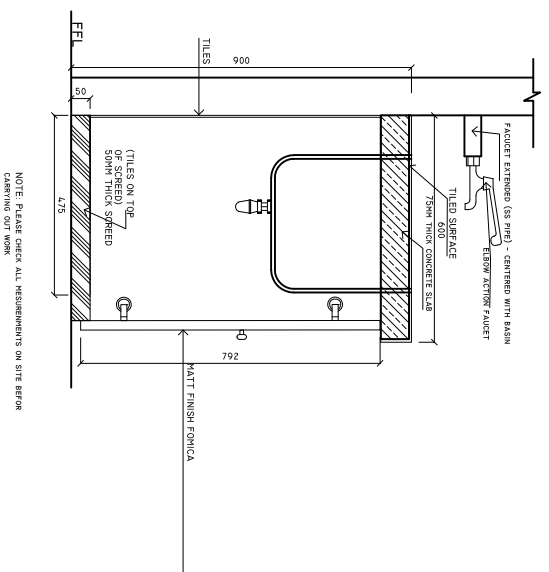

NOTE: PLEASE CHECK ALL MEASUREMENTS ON SITE BEFORE CARRYING OUT WORK

SINK CUPBOARD DETAIL A-A

SCALE: 1 : 20

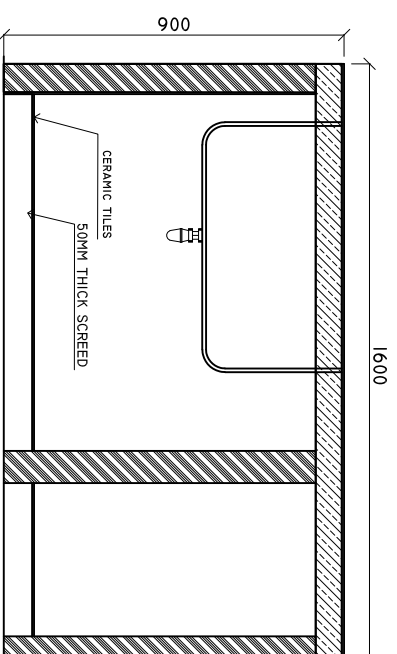

NOTE: PLEASE CHECK ALL MEASUREMENTS ON SITE BEFORE CARRYING OUT WORK

SHEET CONTENTS :

REVISION NOTES:

PROJECT:
CONSTRUCTION OF
SERVICES BUILDING

CLIENT:
MINISTRY OF HEALTH

LOCATION:
MULTIPLE ISLANDS

CONTENTS: AS GIVEN

PROJECT MANAGER:

DESIGNER: ANIZ

CIV/STR. ENGINEER:

SURVEYED BY: -

DRAWN BY: ARIZ

CHECKED BY:

DATE : DEC 2020

PAPER SIZE : A3

SHEET NO. : /



ADMIN DIVISION
Ministry of Health
Roshanee Building
Sasun Malaga
Tel: 332 8887, Fax: 3328889