

Proposed 06 Classroom Block at
K.Huraa School
(02 Storey)

SERVICES DRAWING
Client: Ministry of Education




RIYAN PRIVATE LIMITED

t: +9603315049 f: +9603310776
e: info@riyan.com.mv
w: www.riyan.com.mv
3rd floor, H. Azum, Ameeremaguu, Male'

TABLE OF CONTENTS

DRAWING No.	TITLE	REVISION No.	DATE	REMARKS
A R C H I T E C T U R A L		---	---	---
DR - 01 / 03	GROUND FLOOR DRAINAGE LAYOUT	---	---	---
DR - 02 / 03	1ST FLOOR DRAINAGE LAYOUT	---	---	---
DR - 03 / 03	ROOF DRAINAGE LAYOUT	---	---	---
PL - 01 / 02	GROUND FLOOR PLUMBING LAYOUT	---	---	---
PL - 02 / 02	1ST FLOOR PLUMBING LAYOUT	---	---	---
EL - 01 / 02	GROUND FLOOR LIGHTING LAYOUT	---	---	---
EL - 02 / 02	1ST FLOOR LIGHTING LAYOUT	---	---	---
EP - 01 / 02	GROUND FLOOR POWER LAYOUT	---	---	---
EP - 02 / 02	1ST FLOOR POWER LAYOUT	---	---	---

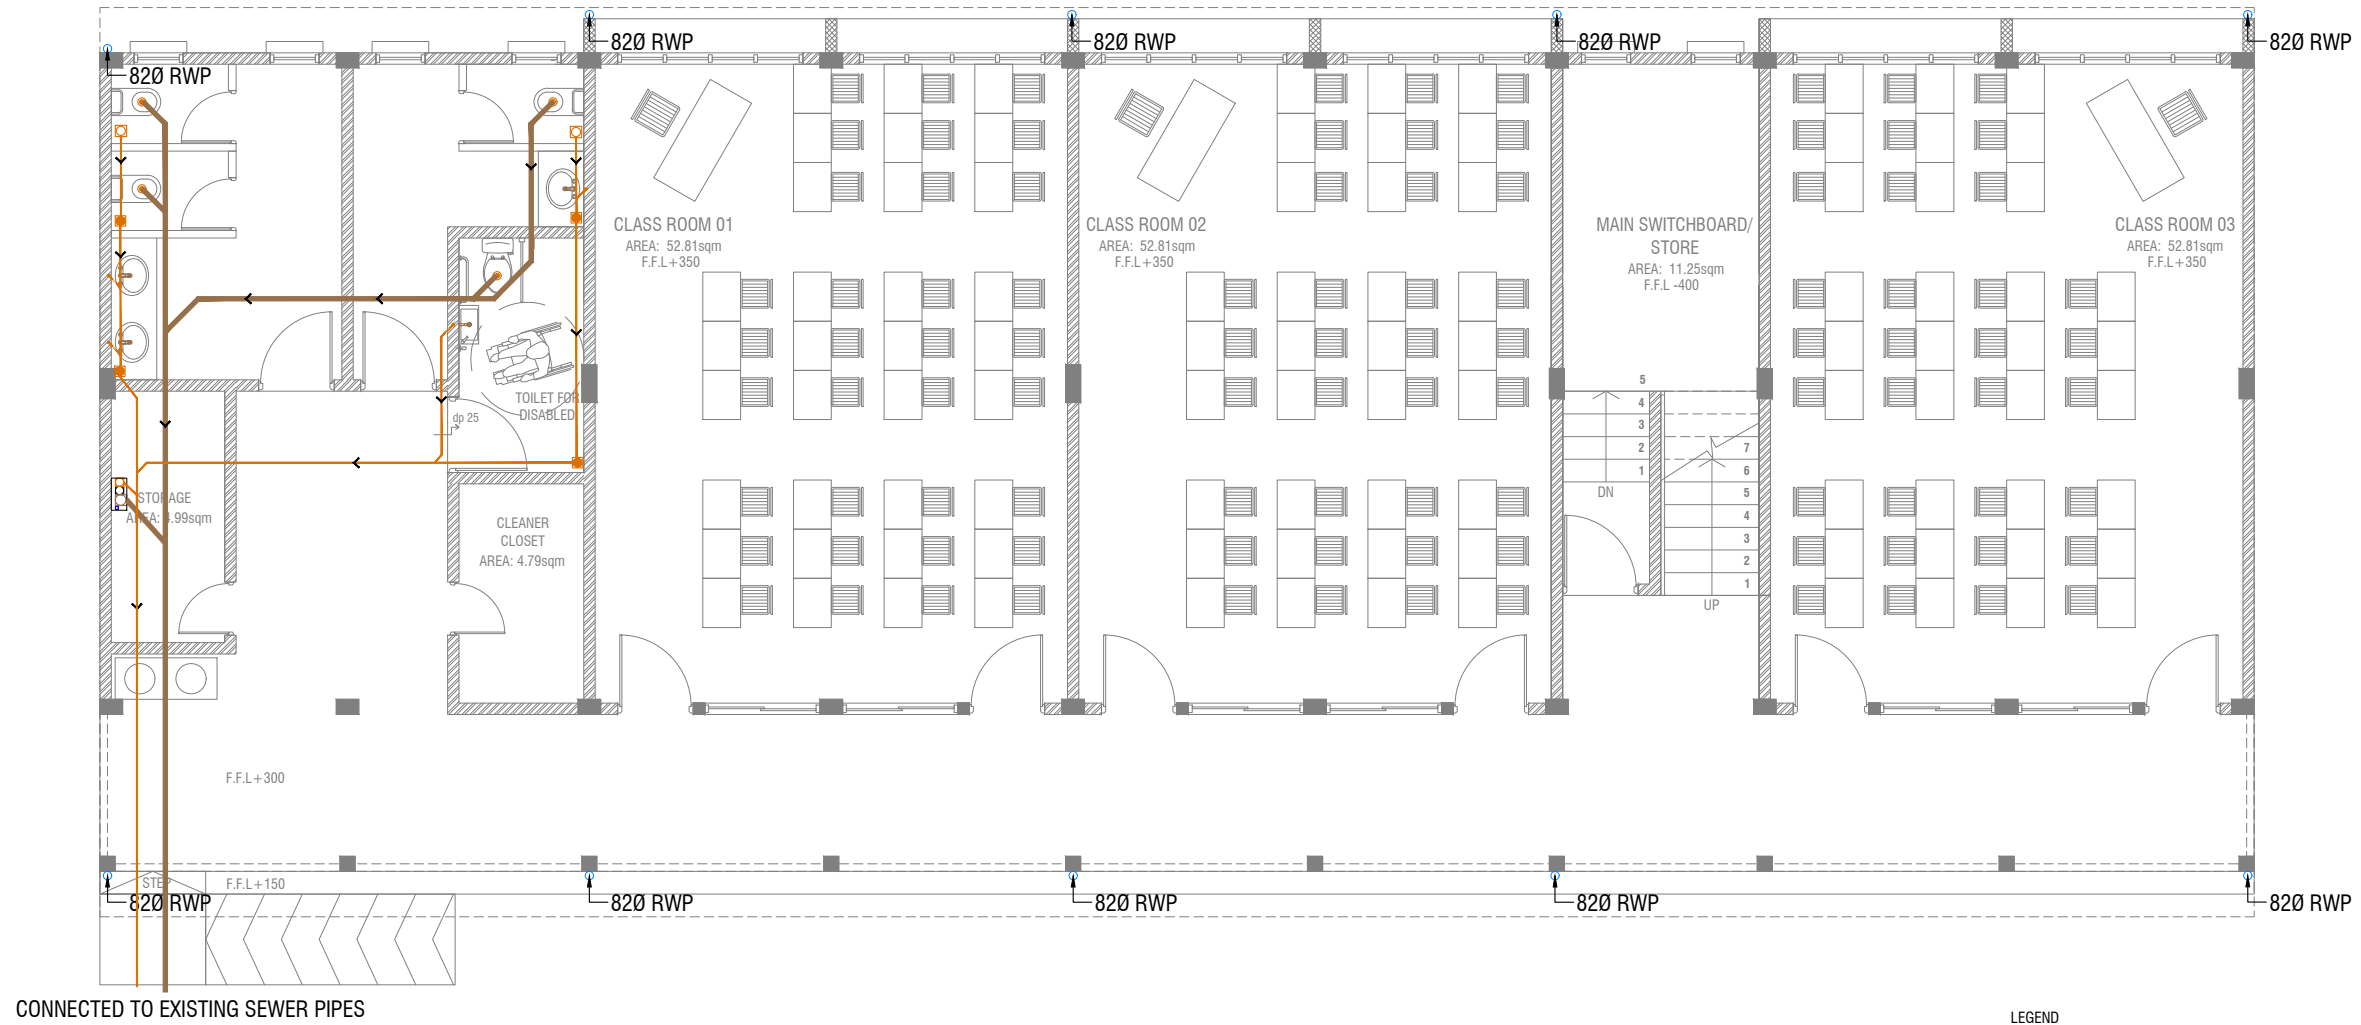

GROUND FLOOR DRAINAGE LAYOUT

SCALE 1:100



LEGEND

- FG FLOOR GULLY
- FD FLOOR DRAIN
- WM 40 Ø STUB FOR WASHING MACHINE
- SP 110 Ø SOIL PIPE
- SVP 110 Ø SOIL VENT PIPE
- WP 82 Ø WASTE PIPE
- WVP 82 Ø WASTE VENT PIPE
- WP 40 Ø WASTE PIPE
- RWP 110 Ø RAINWATER PIPE
- CD 25 Ø DRAIN PIPE
- MHVP 50 Ø MANHOLE VENT PIPE

K. Huraa School - 06 Classroom (02 Storey)
 Client: Ministry of Education

Rev no	Date
1	
2	
3	
4	
5	

Project Number: RI/2017/012
 Date: June 2019
 Architect: Razana Amir
 Engineer: Ahmed Zuhair Zaeem
 Drawn by: Razana Amir
 Services: Alshath Ahmed
 Interior: -




RIYAN PRIVATE LIMITED

t: +9603315049 f: +9603310776
 e: info@riyan.com.mv
 w: www.riyan.com.mv
 3rd floor, H. Azum, Armeenemagu, Male'

Title: Ground Floor
 Drainage Layout

Page: DR 01-03

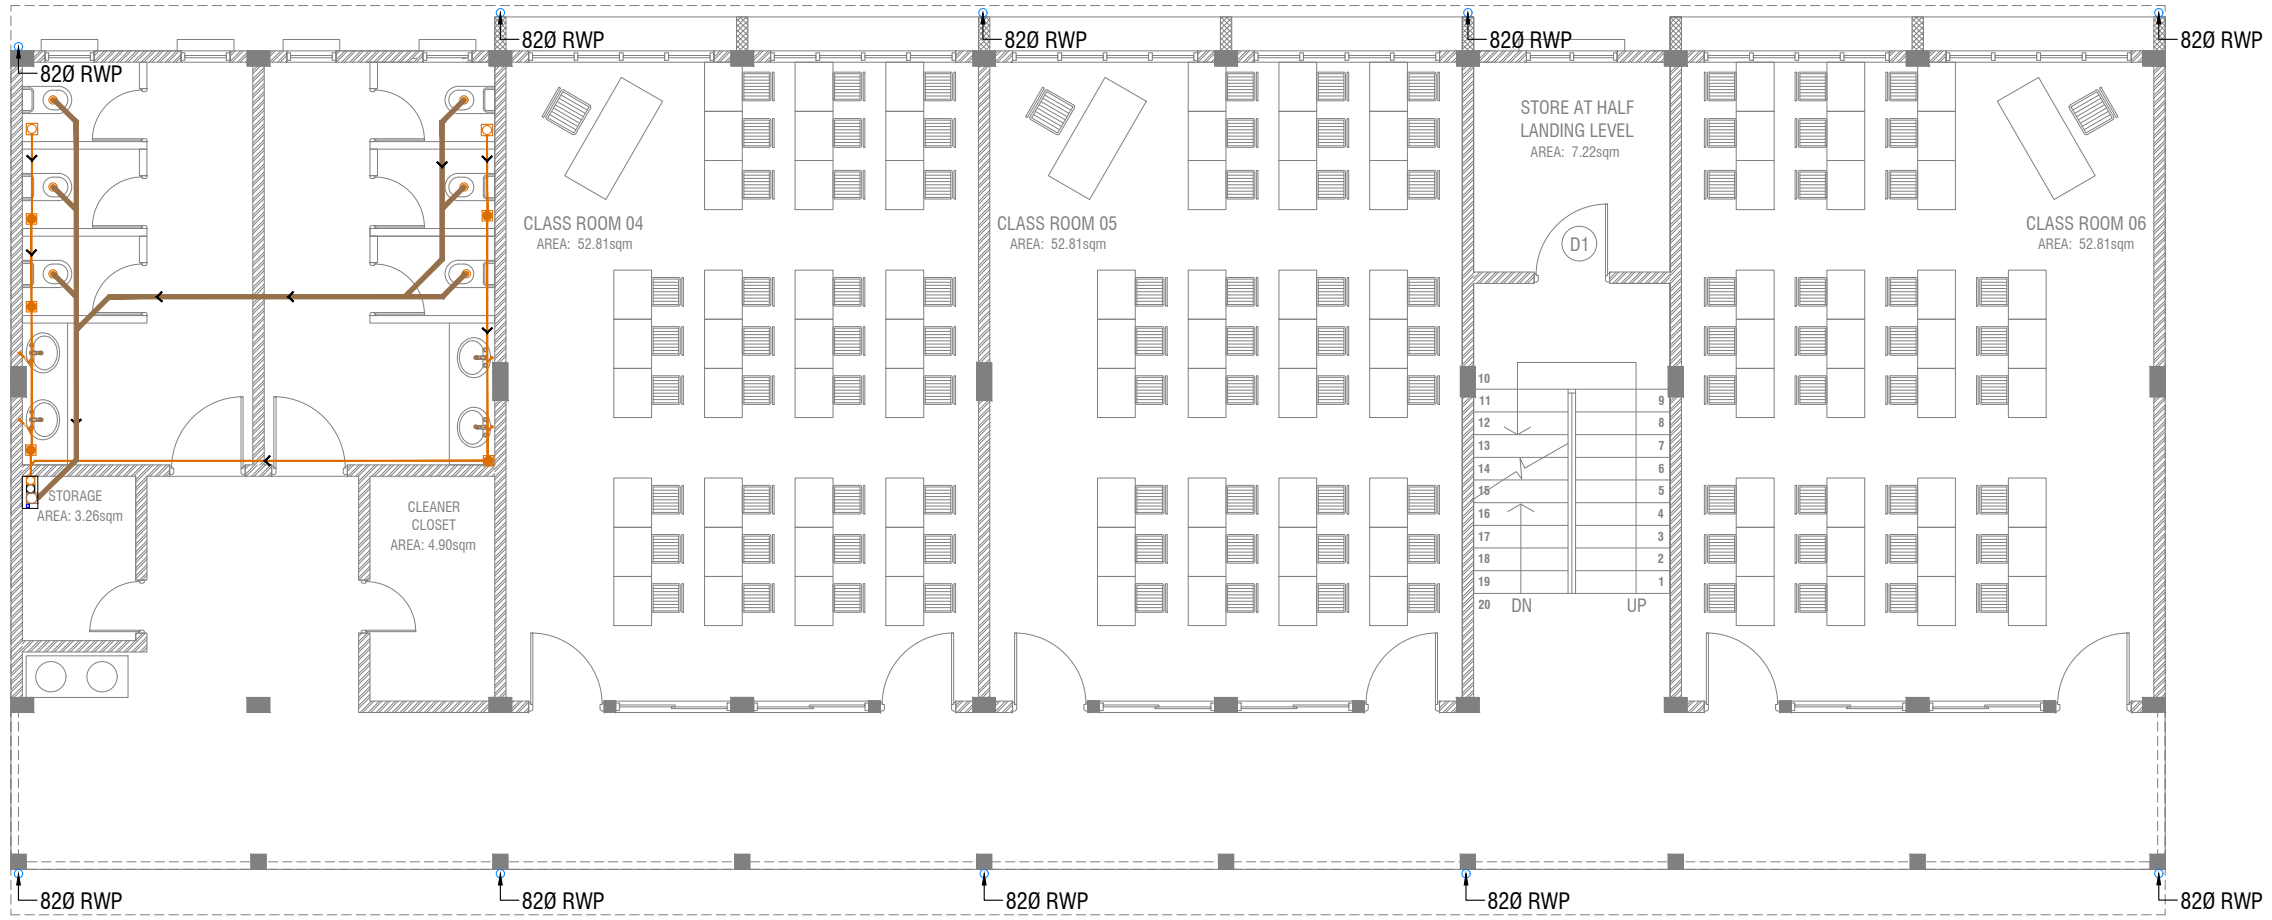

FIRST FLOOR DRAINAGE LAYOUT

SCALE 1:100



LEGEND

- FG FLOOR GULLY
- FD FLOOR DRAIN
- WM 40 Ø STUB FOR WASHING MACHINE
- SP 110 Ø SOIL PIPE
- SVP 110 Ø SOIL VENT PIPE
- WP 82 Ø WASTE PIPE
- WVP 82 Ø WASTE VENT PIPE
- WP 40 Ø WASTE PIPE
- RWP 110 Ø RAINWATER PIPE
- CD 25 Ø DRAIN PIPE
- MHVP 50 Ø MANHOLE VENT PIPE

K.Huraa School - 06 Classroom (02 Storey)
Client: Ministry of Education

Rev no	Date
1	
2	
3	
4	

Project Number: RI/2017/012
Date: June 2019
Architect: Razana Amir
Engineer: Ahmed Zuhair Zaeem
Drawn by: Razana Amir
Services: Alshath Ahmed
Interior: -




RIYAN PRIVATE LIMITED


t: +9603315049 f: +9603310776
e: info@riyan.com.mv
w: www.riyan.com.mv
3rd floor, H. Azum, Ameneemaguu, Male'

Title: First Floor
Drainage Layout

Page: DR 02- 03

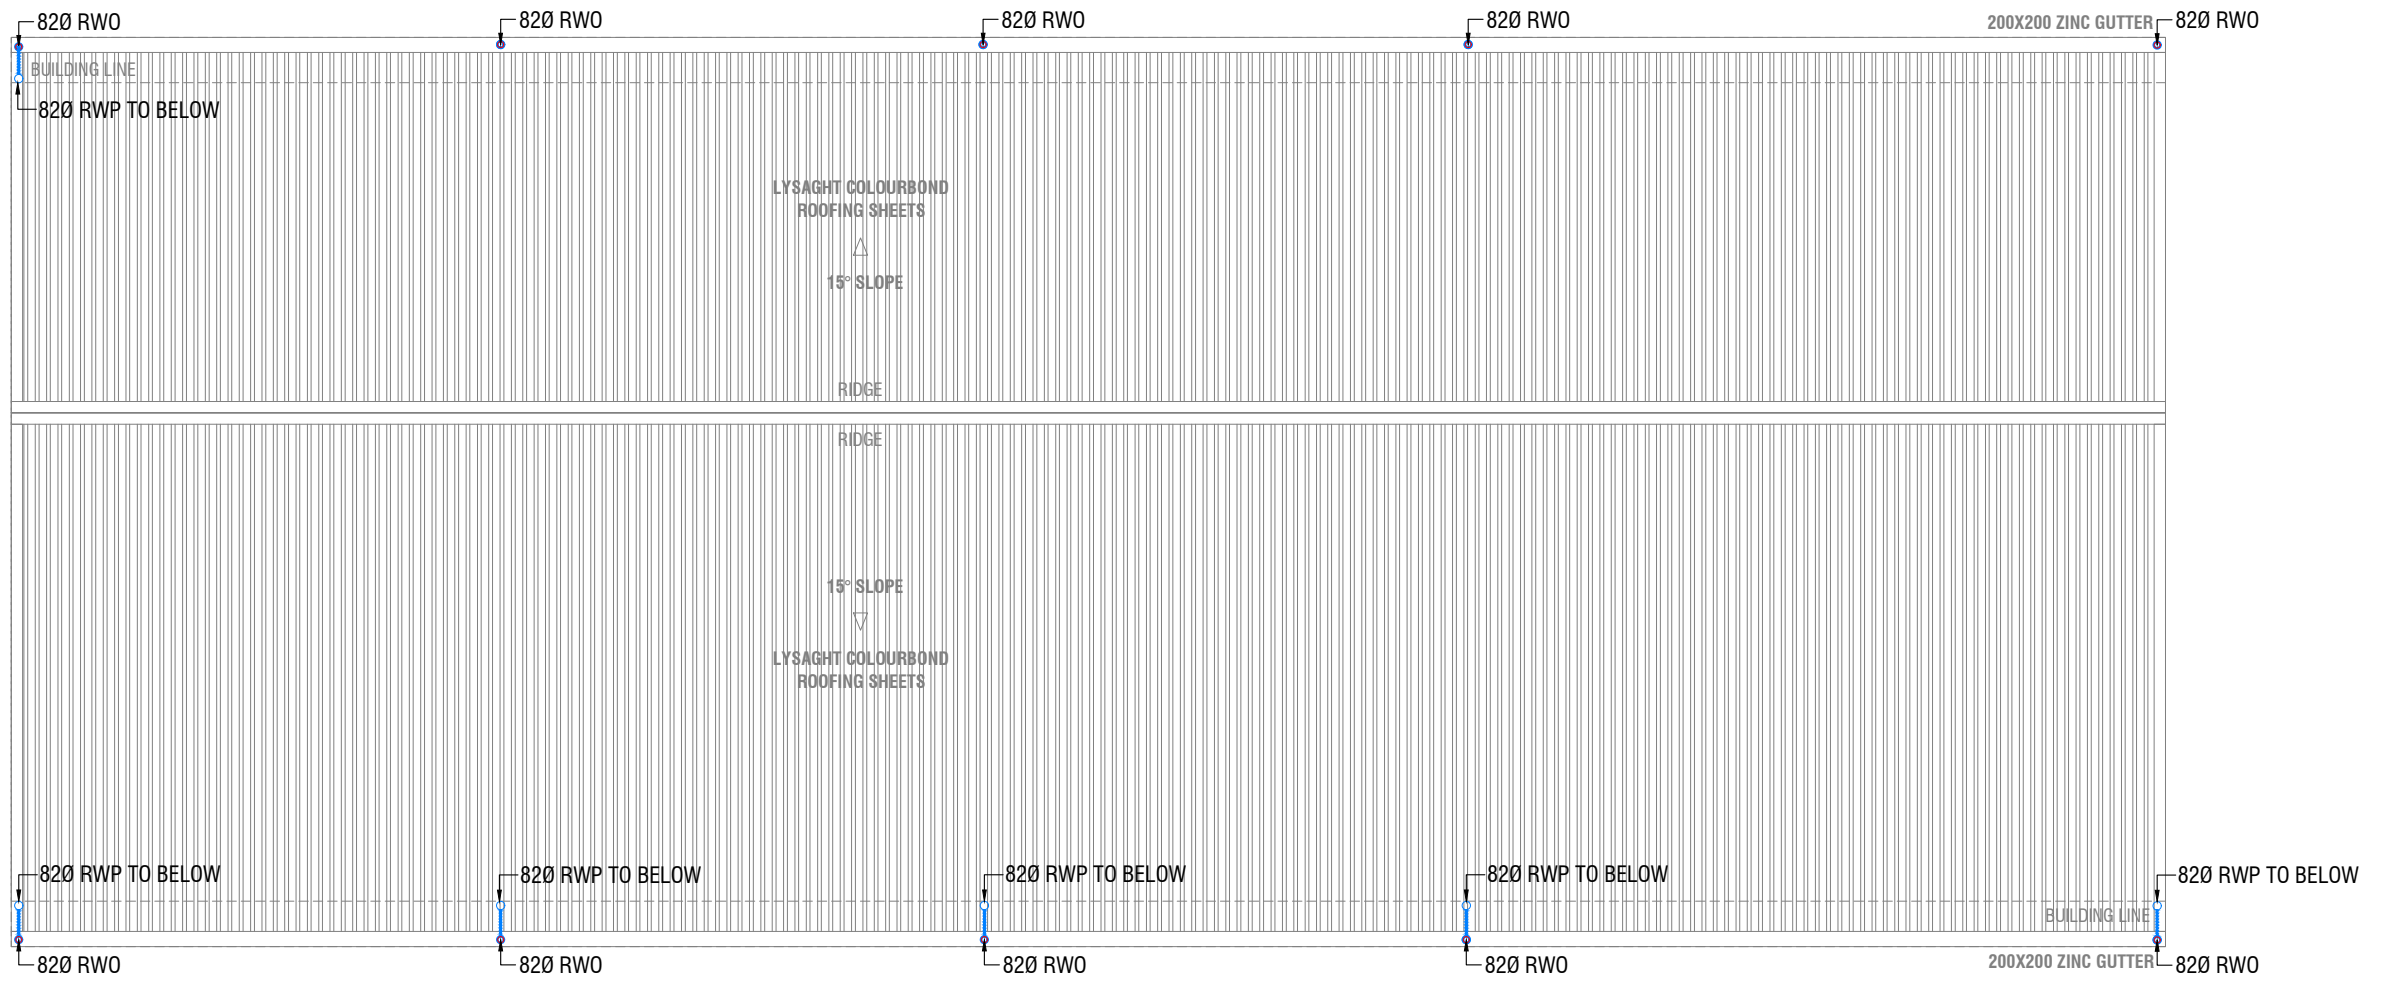

ROOF DRAINAGE LAYOUT

 

- LEGEND**
- FG FLOOR GULLY
 - FD FLOOR DRAIN
 - WM 40 Ø STUB FOR WASHING MACHINE
 - SP 110 Ø SOIL PIPE
 - SVP 110 Ø SOIL VENT PIPE
 - WP 82 Ø WASTE PIPE
 - WVP 82 Ø WASTE VENT PIPE
 - WP 40 Ø WASTE PIPE
 - RWP 110 Ø RAINWATER PIPE
 - CD 25 Ø DRAIN PIPE
 - MHVP 50 Ø MANHOLE VENT PIPE


K.Hurraa School - 06 Classroom (02 Storey)
 Client: Ministry of Education

Rev no	Date
1
2
3
4

Project Number: RI/2017/012
 Date: June 2019
 Architect: Razana Amir
 Engineer: Ahmed Zuhair Zaeem
 Drawn by: Razana Amir
 Services: Alshath Ahmed
 Interior: -



RIYAN PRIVATE LIMITED
 t: +9603315049 f: +9603310776
 e: info@riyan.com.mv
 w: www.riyan.com.mv
 3rd floor, H. Azum, Ameneemagau, Male'

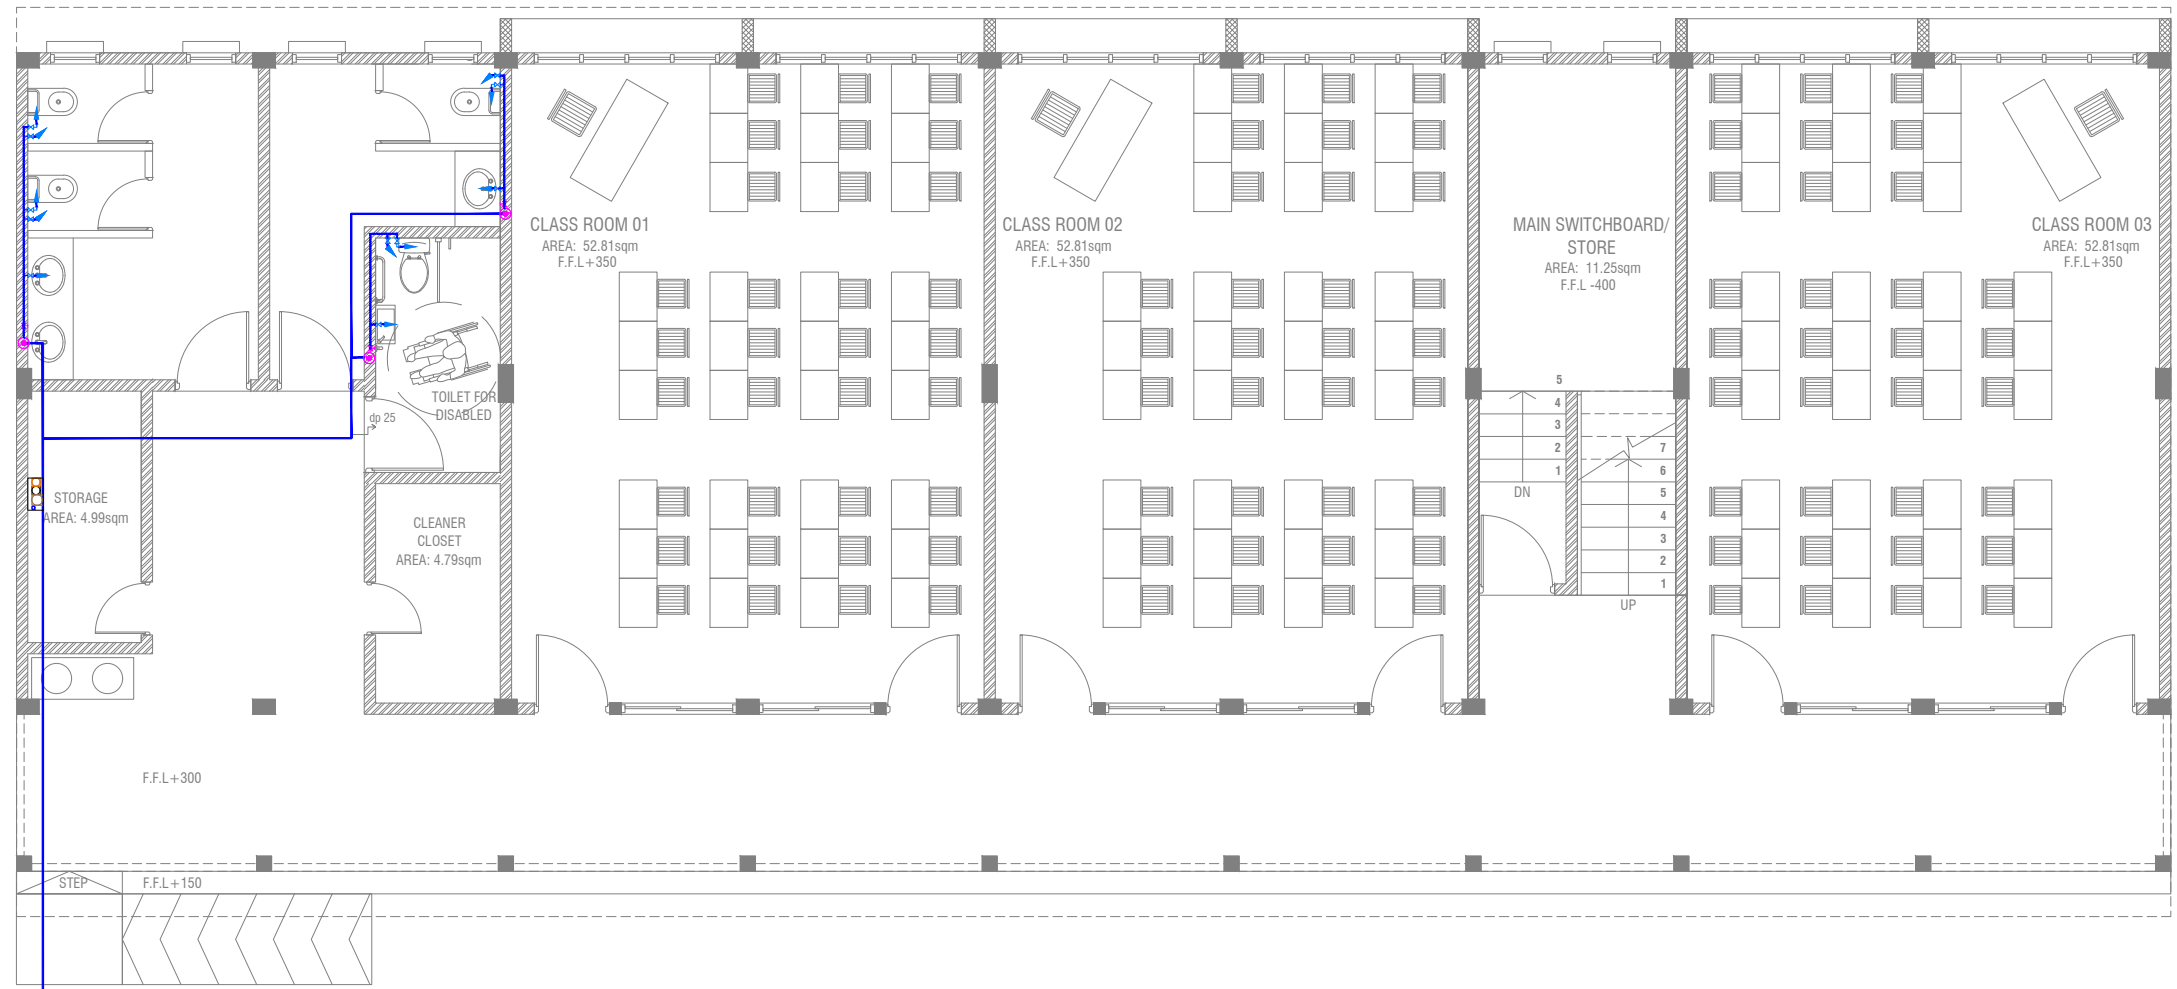

CONNECTED TO EXISTING MAIN WATER PIPE

GROUND FLOOR PLUMBING LAYOUT

SCALE 1:100



LEGEND

- 16 Ø COLD WATER SUPPLY TO CISTERN
- 16 Ø COLD WATER SUPPLY TO BIDET SHOWER
- 16 Ø COLD WATER SUPPLY TO BASIN FAUCET / SINK
- GV GATE VALVE
- 25 Ø COLD WATER SUPPLY PIPES RUN UNDERGROUND
- 25 Ø COLD WATER SUPPLY PIPES RUN IN WALL / UNDER FALSE CEILING
- RISE IN WALL
- DROP IN WALL
- CWS** COLD WATER SUPPLY
- HWS** HOT WATER SUPPLY

K.Hurraa School - 06 Classroom (02 Storey)
Client: Ministry of Education

Project Number: RI/2017/012
Date: June 2019
Architect: Razana Amir
Engineer: Ahmed Zuhair Zaeem
Drawn by: Razana Amir
Services: Alshath Ahmed
Interior: -

Rev no	Date
1	
2	
3	
4	




RIYAN PRIVATE LIMITED

t: +9603315049 f: +9603310776
e: info@riyan.com.mw
w: www.riyan.com.mw
3rd floor, H. Azum, Armeeneemagu, Male'

Title: Ground Floor
Plumbing Layout

Page: PL 01-/02

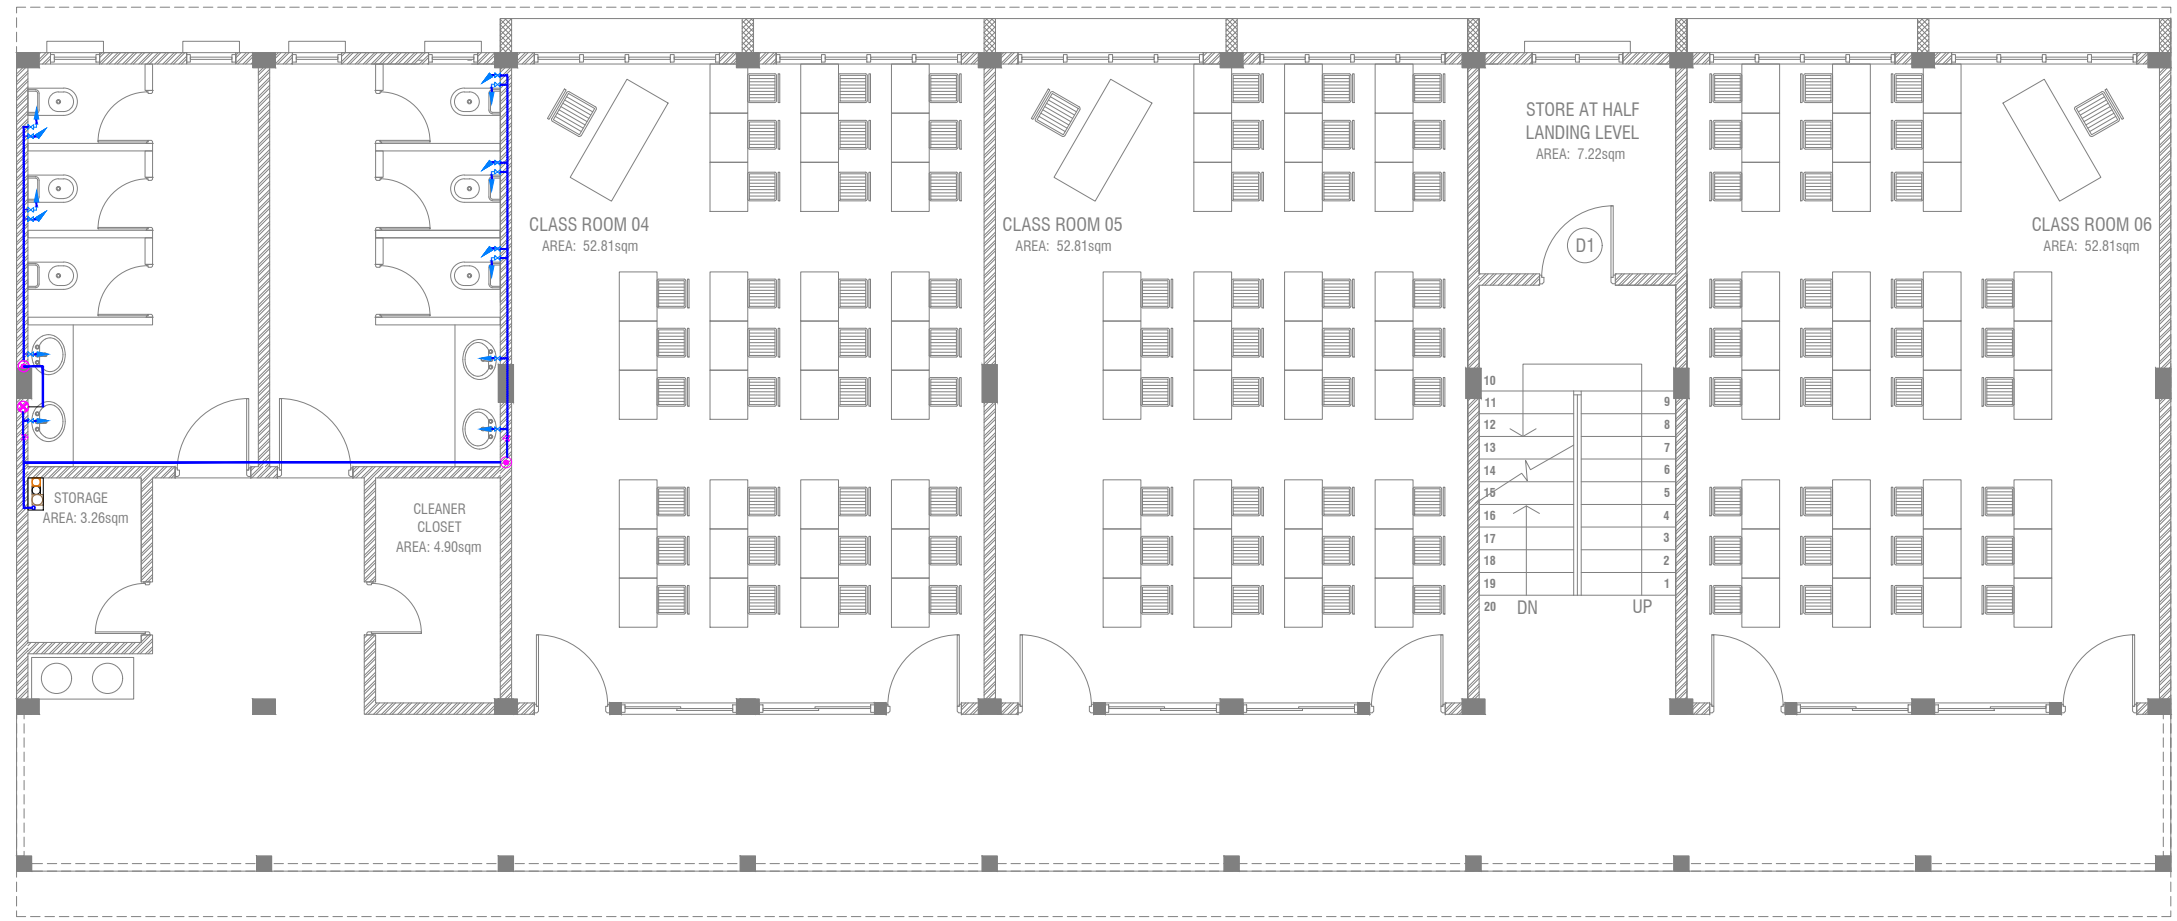

FIRST FLOOR PLUMBING LAYOUT

SCALE 1:100



LEGEND

- 16 Ø COLD WATER SUPPLY TO CISTERN
- 16 Ø COLD WATER SUPPLY TO BIDET SHOWER
- 16 Ø COLD WATER SUPPLY TO BASIN FAUCET / SINK
- GV GATE VALVE
- 25 Ø COLD WATER SUPPLY PIPES RUN UNDERGROUND
- 25 Ø COLD WATER SUPPLY PIPES RUN IN WALL / UNDER FALSE CEILING
- RISE IN WALL
- DROP IN WALL
- CWS** COLD WATER SUPPLY
- HWS** HOT WATER SUPPLY


K.Hurraa School - 06 Classroom (02 Storey)
 Client: Ministry of Education

Rev no	Date

Project Number: RI/2017/012
 Date: June 2019
 Architect: Razana Amir
 Engineer: Ahmed Zuhair Zaeem
 Drawn by: Razana Amir
 Services: Alshah Alshah
 Interior: -



RIYAN PRIVATE LIMITED
 t: +9603315049 f: +9603310776
 e: info@riyan.com.mv
 w: www.riyan.com.mv
 3rd floor, H. Azum, Armeeneemagu, Male'

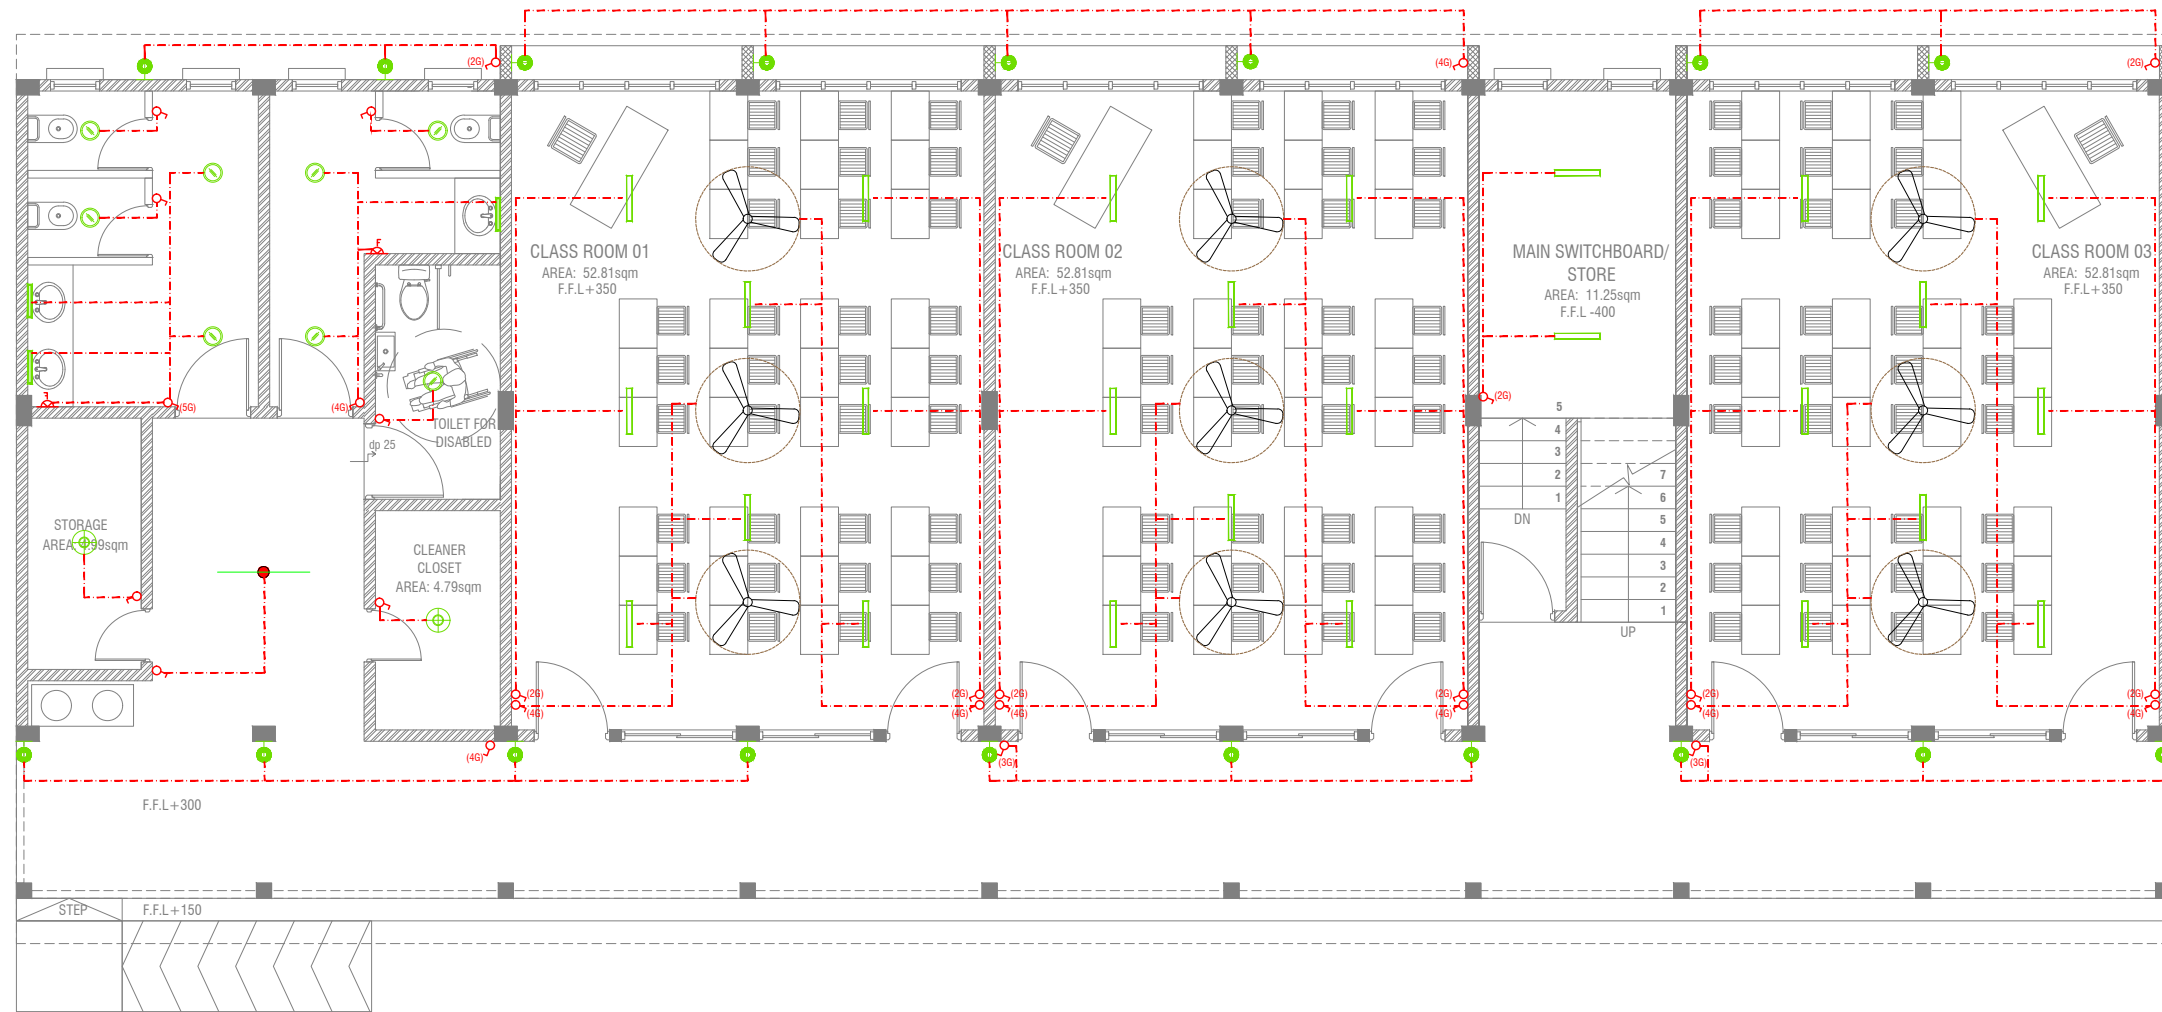

GROUND FLOOR LIGHTING LAYOUT

SCALE 1:100



LEGEND

- WPD OUT DOOR WALL LIGHT
- ML MIRROR LIGHT (7W LED LIGHT)
- H2 RECESSED DOWN LIGHT 12W
- CL CEILING LIGHT 18W CFL
- WP 2 X 4' TUBE LIGHT WITH WEATHER PROOF OPAL CASING
- C2 CEILING DOWN LIGHT (18W)
- LIGHT SWITCH
- SWITCHING LINE

2 X 4' FLUORESCENT LIGHT WITH OPAL CASING



NOTE:
 - ALL WIRING TO BE OF STELCO APPROVED STANDARDS
 - SWITCH CONTROL = 1200MM FROM FLOOR FIN. LEVEL
 - ALL LIGHTING POINTS CONNECTED TO THEIR RESPECTIVE DB


K.Hurraa School - 06 Classroom (02 Storey)
 Client: Ministry of Education

Rev no	Date

Project Number: RI/2017/012
 Date: June 2019
 Architect: Razana Amir
 Engineer: Ahmed Zuhair Zaeem
 Drawn by: Razana Amir
 Services: Alshath Ahmed Interior



RIYAN PRIVATE LIMITED
 t: +9603315049 f: +9603310776
 e: info@riyan.com.mv
 w: www.riyan.com.mv
 3rd floor, H. Azum, Armeenemagu, Male'

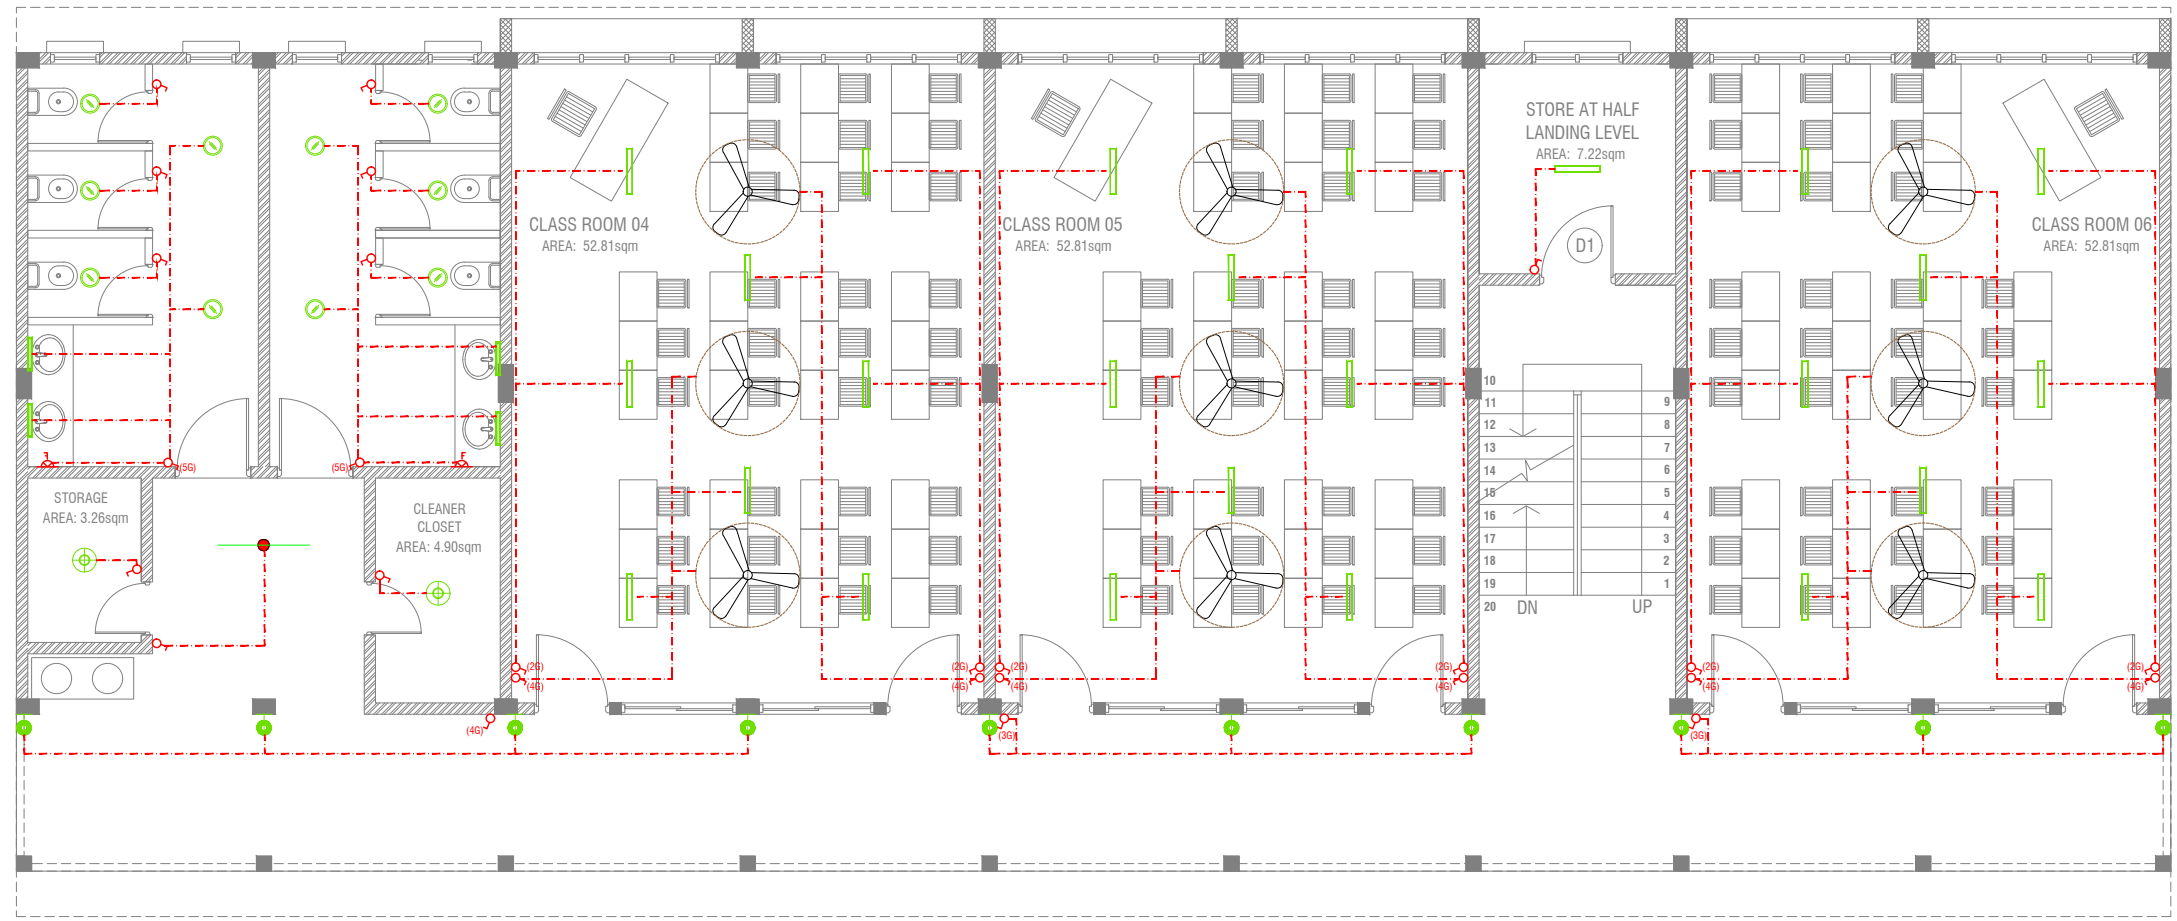

FIRST FLOOR LIGHTING LAYOUT

SCALE 1:100



LEGEND

- WPD OUT DOOR WALL LIGHT
- ML MIRROR LIGHT (7W LED LIGHT)
- H2 RECESSED DOWN LIGHT 12W
- CL CEILING LIGHT 18W CFL
- WP 2 X 4' TUBE LIGHT WITH WEATHER PROOF OPAL CASING
- C2 CEILING DOWN LIGHT (18W)
- LIGHT SWITCH
- SWITCHING LINE

CL2 2 X 4' FLUORESENT LIGHT WITH OPAL CASING




NOTE:
 - ALL WIRING TO BE OF STELCO APPROVED STANDARDS
 - SWITCH CONTROL = 1200MM FROM FLOOR FIN. LEVEL
 - ALL LIGHTING POINTS CONNECTED TO THEIR RESPECTIVE DB

K. Huraa School - 06 Classroom (02 Storey)
 Client: Ministry of Education

Rev no	Date

RIYAN PRIVATE LIMITED
 t: +9603315049 f: +9603310776
 e: info@riyan.com.mv
 w: www.riyan.com.mv
 3rd floor, H. Azum, Armeenemagu, Male'

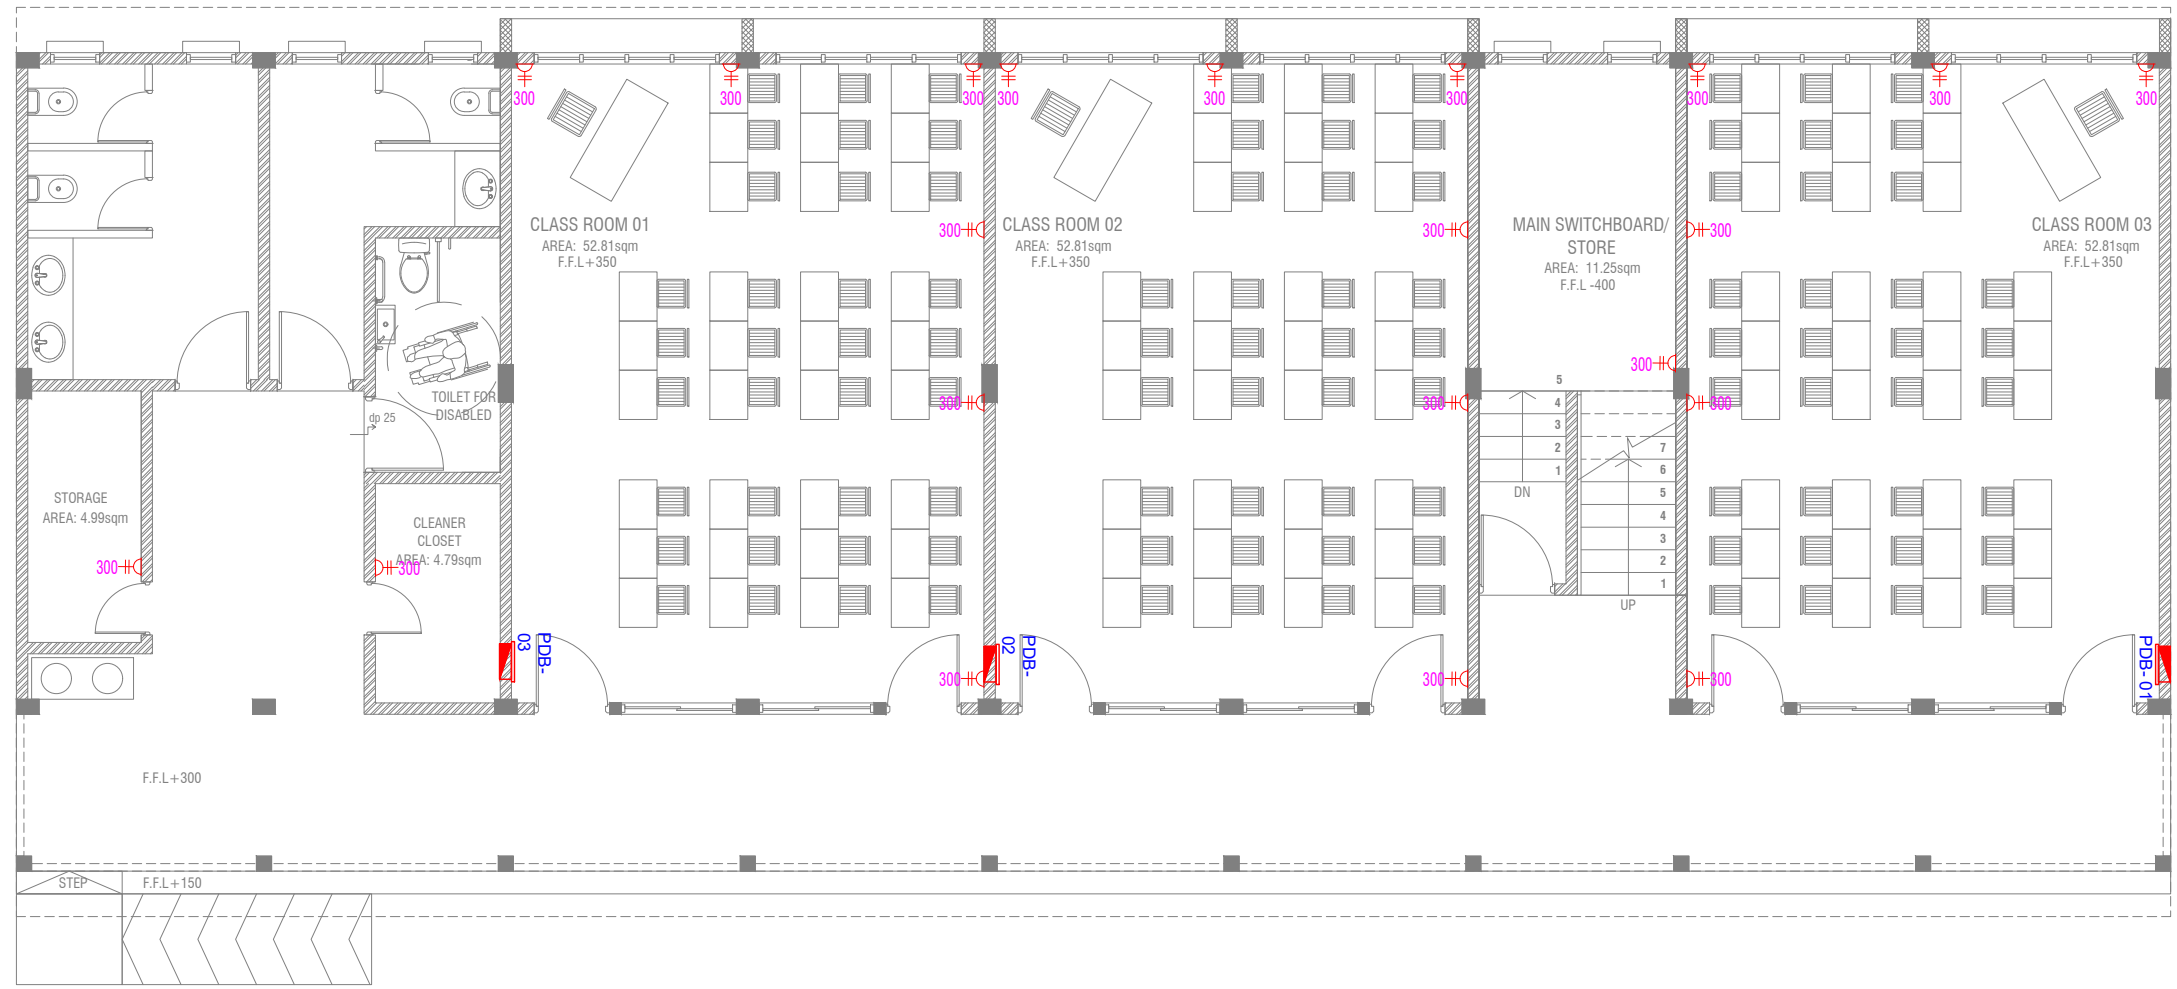

GROUND FLOOR POWER LAYOUT

SCALE 1:100



LEGEND

- PHONE EXTENSION
 - COMPUTER NETWORK OUTLET (RJ 45 CONNECTORS)
 - TELEPHONE OUTLET (RJ11, CONNECTOR)
 - 13A POWER OUTLET
 - 13A TWIN SOCKET OUTLET
 - TPN ISOLATOR
 - VGA CABLE FOR PROJECTOR
 - DISTRIBUTION BOX
 - 15A.SWITCHED/ SPUR UNIT @ H.L.
 - TWO GANG TV/SAT SOCKET OUTLET
 - HL. HIGH LEVEL
 - WPE WEATHER PROOF POLYCARBONATE ENCLOSURE
- ALL ELECTRICAL COMPONENT TO BE CONNECTED TO THEIR RESPECTIVE DB


K.Hurraa School - 06 Classroom (02 Storey)
Client: Ministry of Education

Rev no	Date

Project Number: RI/2017/012
Date: June 2019
Architect: Razana Amir
Engineer: Ahmed Zuhair Zaeem
Drawn by: Razana Amir
Services: Alshath Ahmed
Interior: -



RIYAN PRIVATE LIMITED
t: +9603315049 f: +9603310776
e: info@riyan.com.mw
w: www.riyan.com.mw
3rd floor, H. Azum, Armeeneemagu, Male'

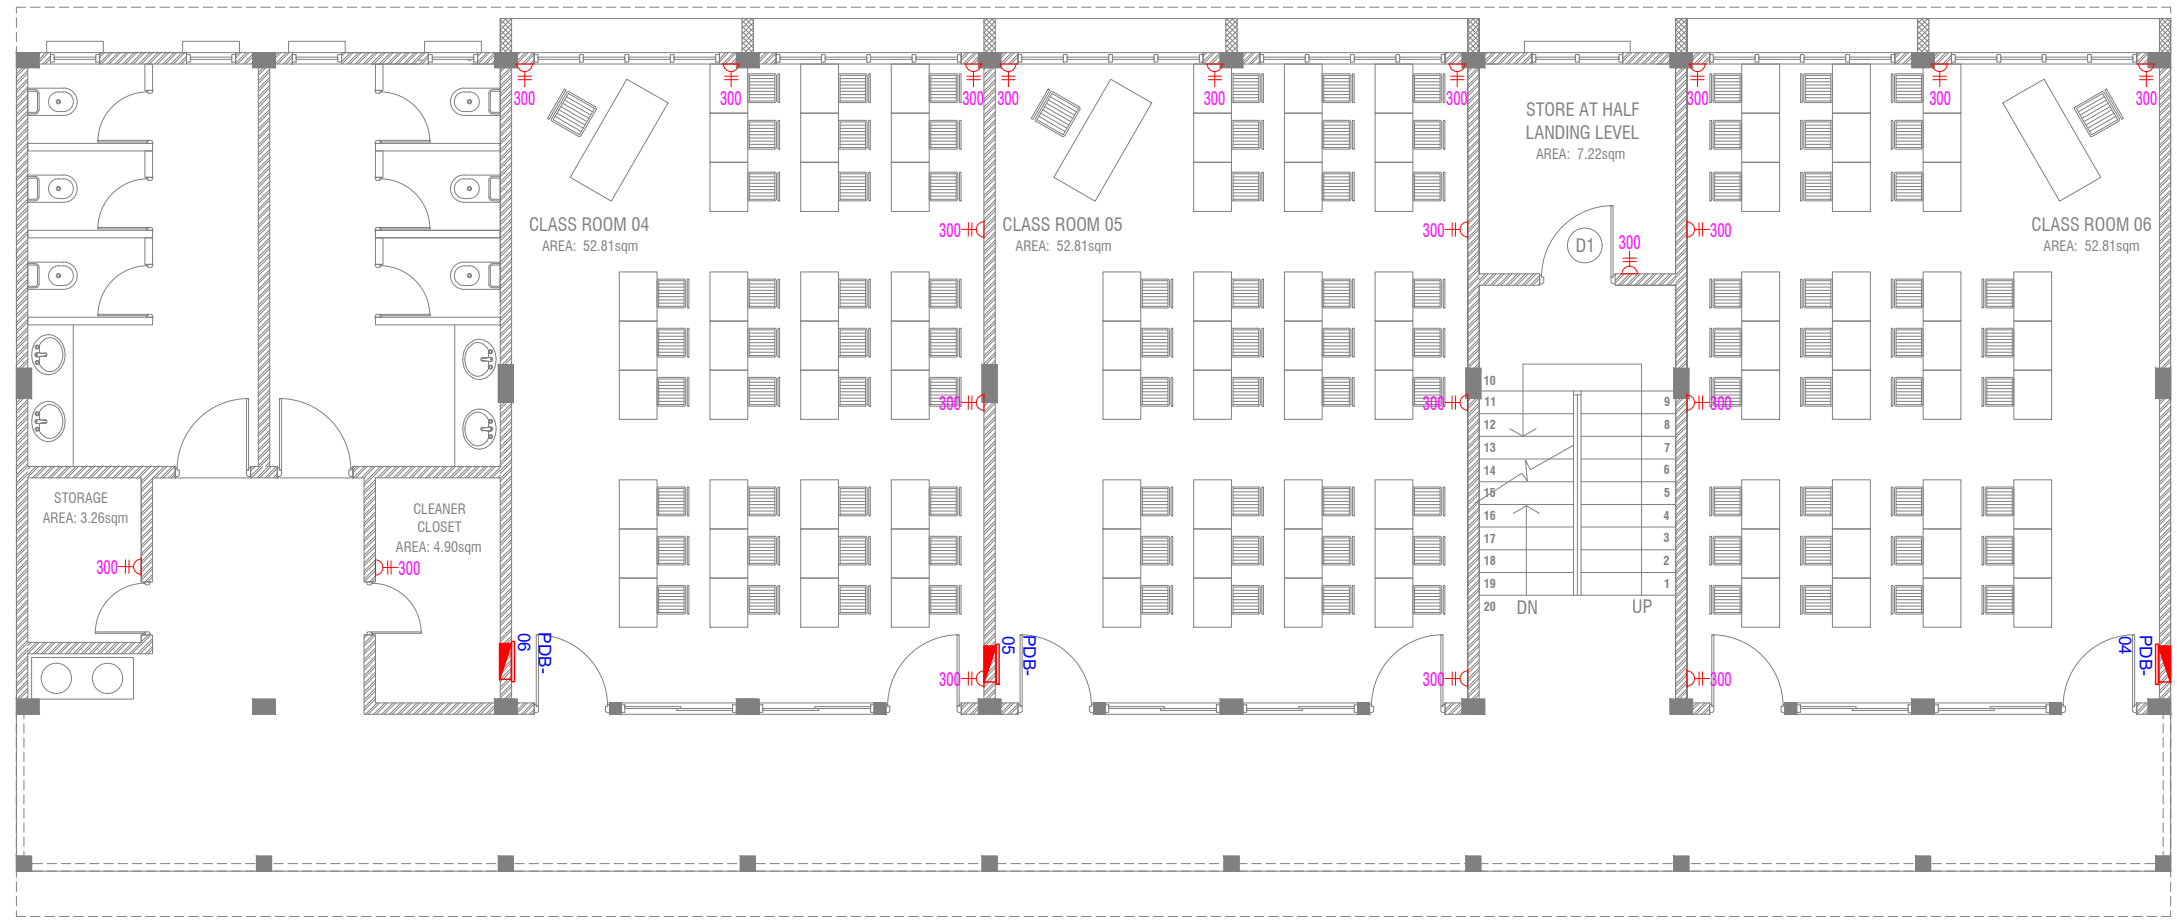

FIRST FLOOR POWER LAYOUT

SCALE 1:100



LEGEND

- PHONE EXTENSION
- COMPUTER NETWORK OUTLET (RJ 45 CONNECTORS)
- TELEPHONE OUTLET (RJ11, CONNECTOR)
- 13A POWER OUTLET
- 13A TWIN SOCKET OUTLET
- TPN ISOLATOR
- VGA CABLE FOR PROJECTOR
- DISTRIBUTION BOX
- 15A SWITCHED/ SPUR UNIT @ H.L.
- TWO GANG TV/SAT SOCKET OUTLET
- H.L. HIGH LEVEL
- WPE WEATHER PROOF POLYCARBONATE ENCLOSURE

ALL ELECTRICAL COMPONENT TO BE CONNECTED TO THEIR RESPECTIVE DB

K.Hurra School - 06 Classroom (02 Storey)
Client: Ministry of Education

Rev no	Date

Project Number: RI/2017/012
Date: June 2019
Architect: Razana Amir
Engineer: Ahmed Zuhair Zaeem
Drawn by: Razana Amir
Services: Alshath Ahmed
Interior: -



RIYAN PRIVATE LIMITED
t: +9603315049 f: +9603310776
e: info@riyan.com.mv
w: www.riyan.com.mv
3rd floor, H. Azum, Armeenemagu, Male'