



RECEPTION



PRESENTATION AREA



OPEN WORK AREA



OPEN WORK AREA



CAFE



MEET / WORK 2

No.	Description	Date


PROJECT NAME:  
MEERY PROJECT

DRAWING:  
COVER PAGE

SCALE:                      DATE:  
  SEP 29, 2020

DRAWN BY:                 CHECKED BY:  
LD    NK    ZM

DRAWING NO.            ID0.0

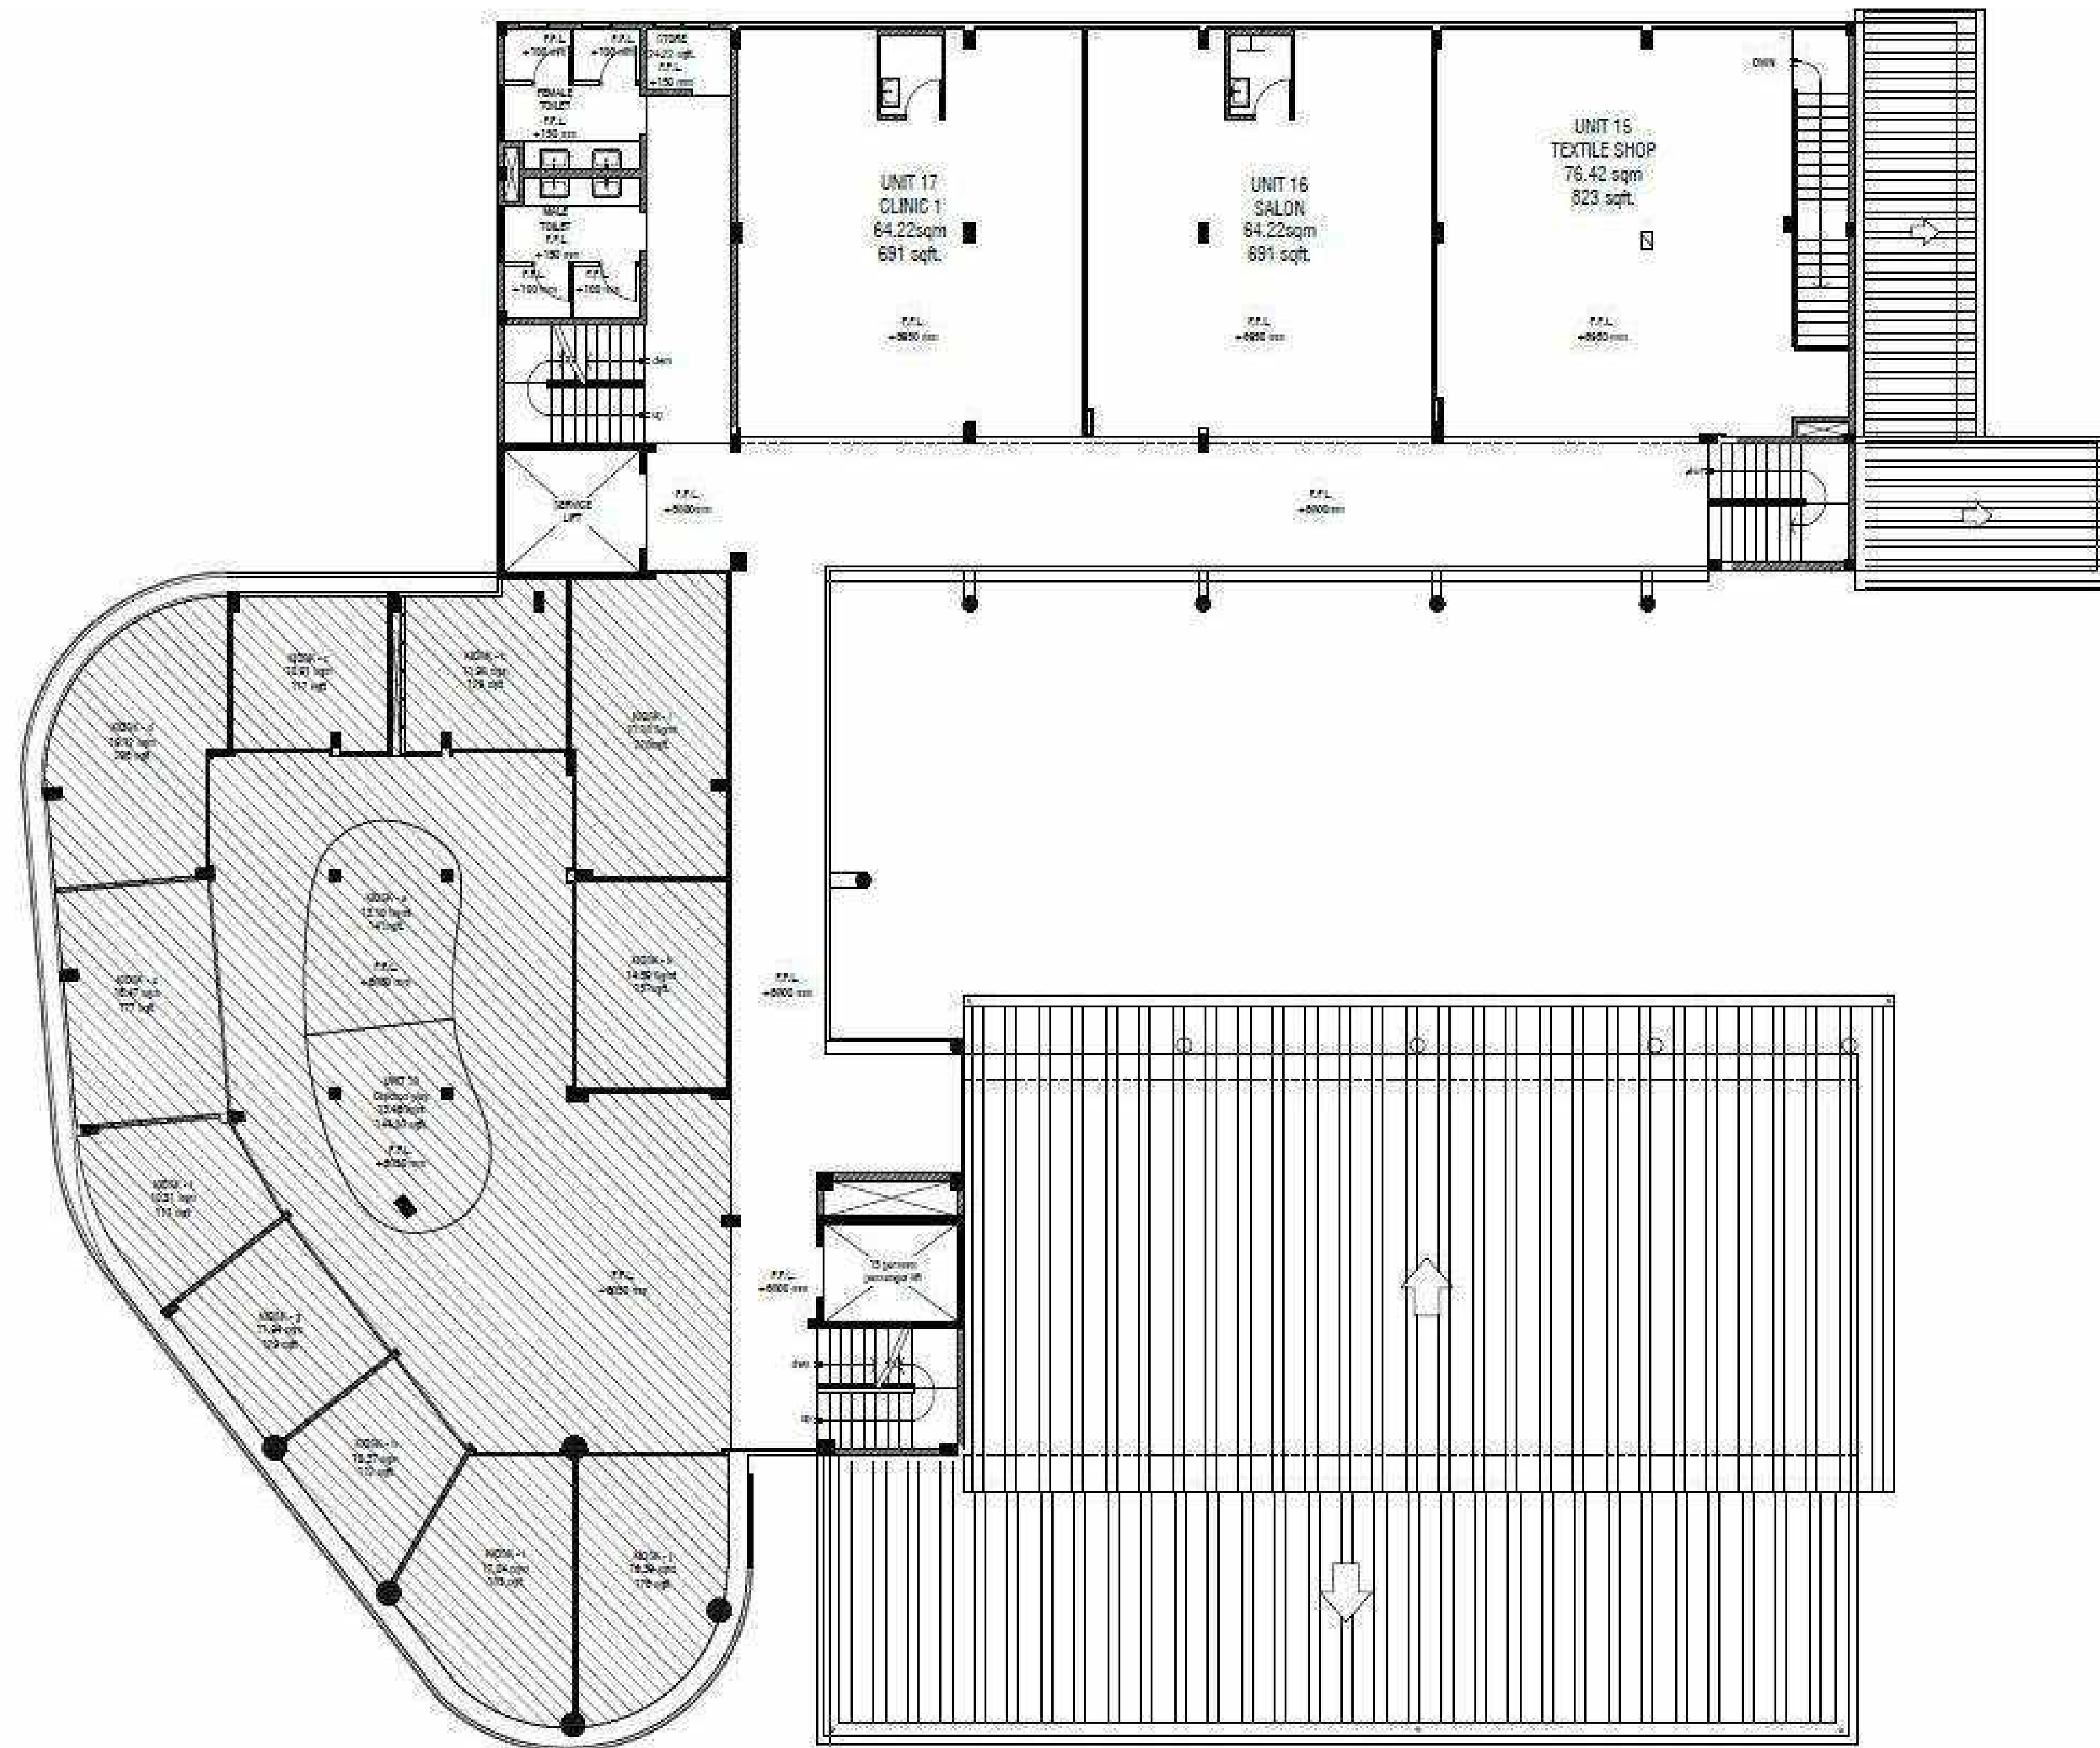

KEY PLAN FOR LOCATION  
LOT 11131 CENTRO MALL

GENERAL NOTES

1. All materials and workmanship to be of the highest possible standard.
2. Contractor to verify existing site conditions and all job dimensions, drawings, and specifications.
3. All work to conform to the Maldives National Building Code.
4. All materials to be of non-combustible construction as required by local building codes and regulations.
5. Contractor to make good all existing areas affected by work. Repair or replace any existing materials, finishes, light fixtures, hardware, etc. which are to remain.
6. Where applicable, fire-rated ceilings, partitions and doors to be provided to meet local building codes and regulations.
7. Appropriate concealed blocking and/or reinforcing steel to be provided in all new and existing walls as required to support new wall fixtures and shelves.
8. Appropriate concealed blocking and/or reinforcing steel to be provided in all new and existing ceilings as required to support new light fixtures, suspended ceilings, decorative elements, signage, etc.
9. Contractor to price, produce/manufacture, all finishes and materials as per general finishes schedule and drawings provided. Use of "equal" alternatives are subject to client's approval.
10. All exposed ceilings including existing wood deck, conduits, ducts, sprinkler lines, etc. to receive specified paint finish, unless indicated otherwise on drawings.
11. Contractor to ensure all glass edges to have safety bevel.
12. Do not scale drawings.

INTERIOR DESIGN DRAWING LIST

DRAWING NUMBER	DRAWING NAME
ID0.0	COVERPAGE
ID0.00	TITLE SHEET
ID1.0	DEMOLITION PLAN
ID1.1	PARTITION PLAN
ID1.2	REFLECTED CEILING PLAN
ID1.3	FURNITURE AND EQUIPMENT PLAN
ID1.4	FINISHES PLAN
ID1.5	POWER AND COMMUNICATIONS PLAN
ID2.1	INTERIOR ELEVATIONS
ID3.1	WOOD SLAT PARTITION DETAILS
ID3.2	RECEPTION WOOD WALL AND BENCH DETAILS
ID3.3	RECEPTION WOOD WALL DETAILS
ID3.4	STOREFRONT CLOSURE REFERENCE SHEET

No.	Description	Date


PROJECT NAME:  
MEERY PROJECT

DRAWING:  
TITLE SHEET

SCALE: N/A DATE: SEP 29, 2020


DRAWN BY: LD NK CHECKED BY: ZM

DRAWING NO. ID0.00

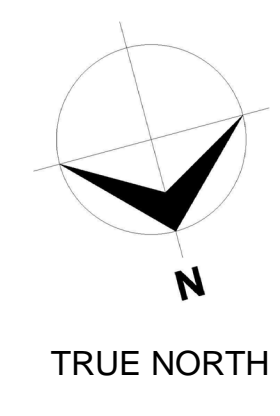

 




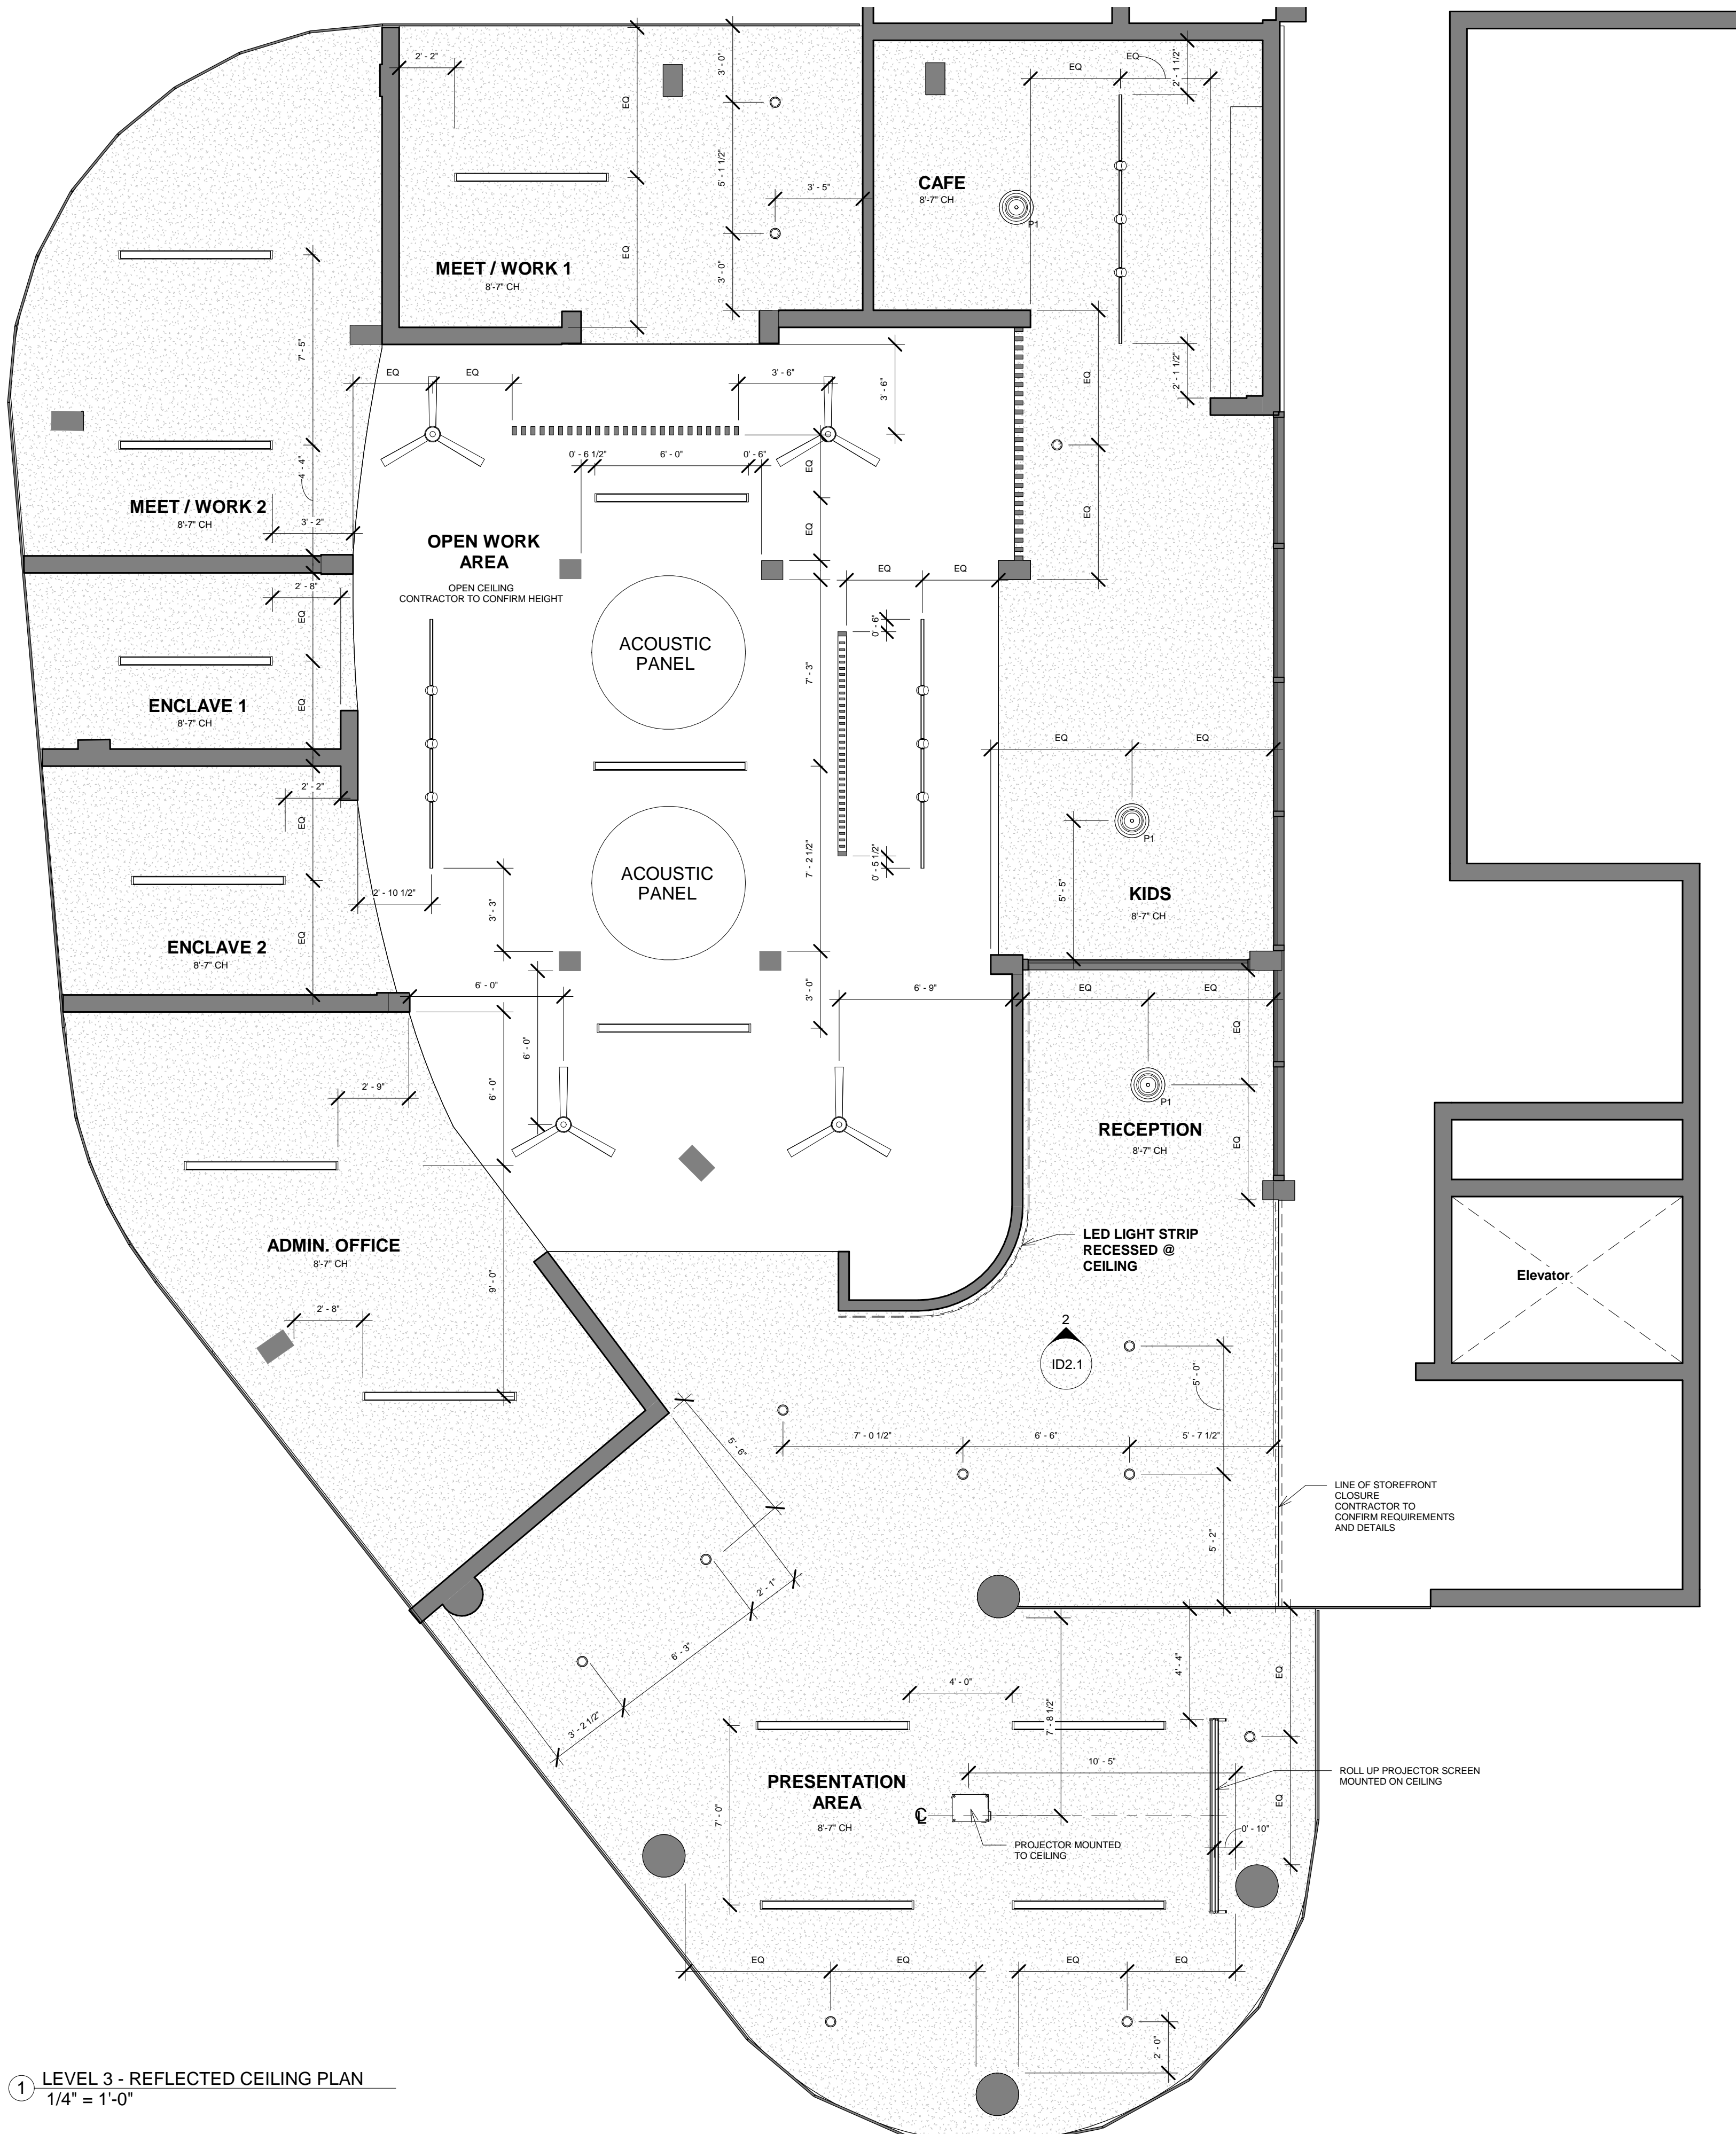


1 LEVEL 3 - REFLECTED CEILING PLAN  
1/4" = 1'-0"





 



 



 

 

### CEILING SCHEDULE

-  DRYWALL CEILING @ 8'-7" +/- AFF
-  OPEN CEILING PAINTED (CONTRACTOR TO CONFIRM HEIGHT)

### GENERAL NOTES

1. All materials and workmanship to be of the highest possible standard.
2. Contractor to verify existing site conditions and all job dimensions, drawings, and specifications.
3. All work to conform to the Maldives National Building Code.
4. All materials to be of non-combustible construction as required by local building codes and regulations.
5. Contractor to make good all existing areas affected by work. Repair or replace any existing materials, finishes, light fixtures, hardware, etc. which are to remain.
6. Where applicable, fire-rated ceilings, partitions and doors to be provided to meet local building codes and regulations.
7. Appropriate concealed blocking and/or reinforcing steel to be provided in all new and existing walls as required to support new wall fixtures and shelves.
8. Appropriate concealed blocking and/or reinforcing steel to be provided in all new and existing ceilings as required to support new light fixtures, suspended ceilings, decorative elements, signage, etc.
9. Contractor to price, produce/manufacture, all finishes and materials as per general finishes schedule and drawings provided. Use of "equal" alternatives are subject to client's approval.
10. All exposed ceilings including exiting wood deck, conduits, ducts, sprinkler lines, etc. to receive specified paint finish, unless indicated otherwise on drawings.
11. Contractor to ensure all glass edges to have safety bevel.
12. Do not scale drawings.

### LIGHTING SCHEDULE

SYMBOL	LOCATION	# OF ITEMS	DESCRIPTION	SIZE	MANUFACTURE R / SUPPLIER	IMAGE
	THROUGHOUT	11	4 INCH ROUND ALL-PURPOSE LED RETROFIT MODULE LCR4 LED DIRECT MOUNT	6.42" DIA x 2.09" H LIGHT SIZE: 4" DIA.	COOPER LIGHTING SOLUTIONS	
	THROUGHOUT	14	CONTINUA SQ4 SUSPENDED, 6' SUSPENDED @ 8' AFF	6"W x 4"H x 4"D	COOPER LIGHTING SOLUTIONS	
	OPEN WORK AREA, CAFE	2	TRACK LIGHT LZR308 FLATBACK CYLINDER WITH BAFFLE WHITE SUSPENDED @ 8' AFF	4"DIA. x 9"H x 5 7/16"D	COOPER LIGHTING SOLUTIONS	
	RECEPTION, KIDS, CAFE	3	PENDANT, GERE LPC4357 SUSPENDED @ 7' AFF	22"H x 16" DIA.	RENWIL	
	OPEN WORK AREA	4	ROBOTO 52" 3000K LED CEILING FAN 1222840 MATTE WHITE SUSPENDED @ 8' AFF	52"W	ROBINSON	
	PRESENTATION AREA	1	PROJECTOR SCREEN MANUAL B SERIES MAX WHITE	120"W x 100"H	ELITE SCREENS	
	PRESENTATION AREA	1	HOME CINEMA 660 3LCD PROJECTOR, CEILING MOUNT V11H847020	N/A	EPSON	
	RECEPTION	1	LED STRIP A2835 - 120 - 30K - V48 - NWP	10mm W	COXO	

No.	Description	Date

PROJECT NAME:  
MEERY PROJECT

DRAWING:  
REFLECTED CEILING PLAN


SCALE:  
As indicated


DATE:  
SEP 29, 2020

DRAWN BY:  
LD NK

CHECKED BY:  
ZM

DRAWING NO.  
ID1.2

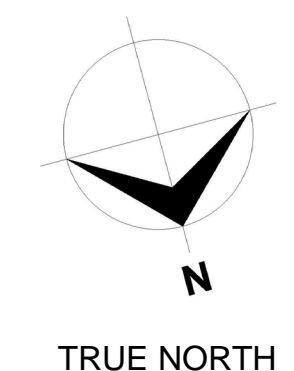

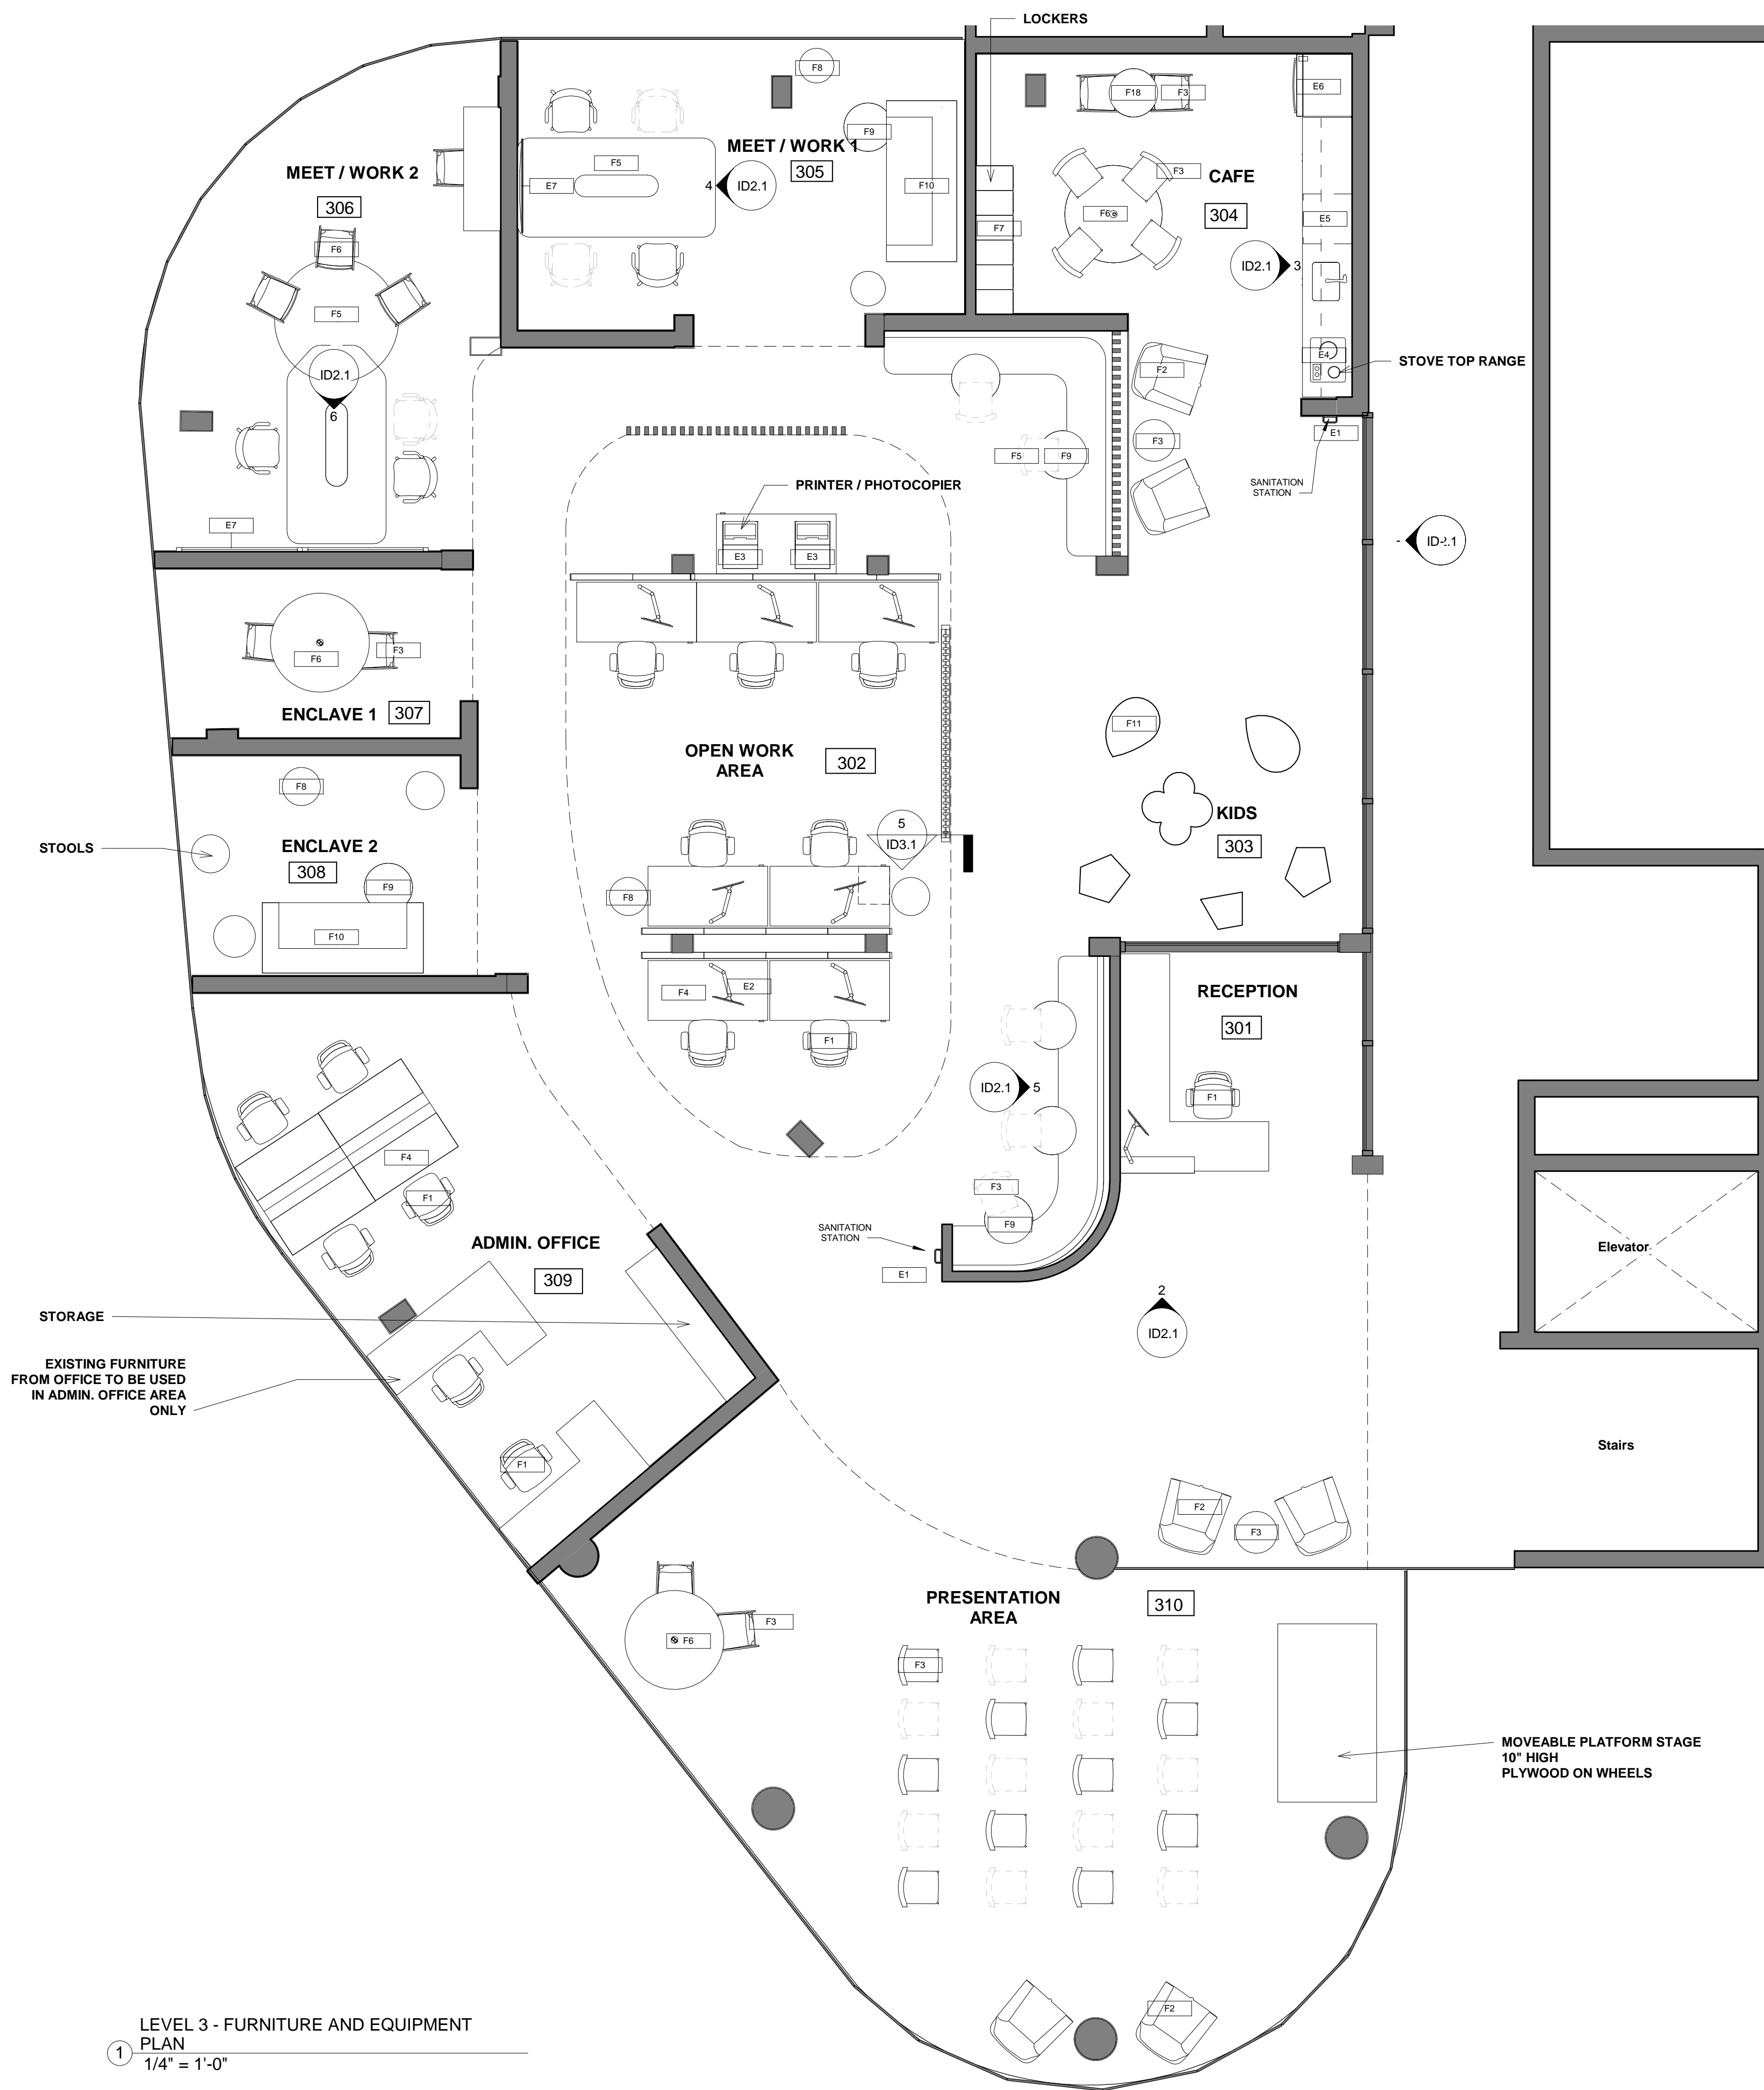

## FURNITURE SCHEDULE

KEY	DESCRIPTION	DIMENSIONS H x W x D	MANUFACTURER /SUPPLIER	CODE/SERIES	COST	IMAGE	QUANTITY
F1	OFFICE TASK CHAIR	N/A	BUY RAINBOW	LOW BACK MESH CHAIR WITH ARMREST & MT BASE WYEN-66-B22	MVR 3,445.00 (Incl. GST)		15
F2	LOUNGE CHAIR	81cm H 53cm W 73cm D	BUY RAINBOW	CHAIR "TIFFANY" 3517920643879	MVR 2,385.00 (Incl. GST)		6
F3	STACKABLE CHAIR	80cm H 55cm W 57cm D	BUY RAINBOW	CHAIR R408-TB001	MVR 3,498.00 (Incl. GST)		38
F4	DESK	75cm H 120cm W 70cm D	BUY RAINBOW	WRITING TABLE GT127-DGM (STORAGE SOLD SEPARATELY)	MVR 1,287.90 (Incl. GST)		7
F5	CONFERENCE TABLE	76cm H 180cm W 90cm D	BUY RAINBOW	OVAL CONFERENCE TABLE GO18-DGM	MVR 2,226.00 (Incl. GST)		2
F6	TABLE	75cm H 120cm D	BUY RAINBOW	ROUND MEETING TABLE WITH METAL STAND QR120-FM	MVR 2,416.80 (Incl. GST)		4
F7	LOCKER	183cm H 38cm W 45.7cm D	BUY RAINBOW	STEEL LOCKER 2 COMPARTMENTS WITH HANGER ROD L552B-1HR	MVR 1,855.00 (Incl. GST)		6
F8	STOOLS	N/A	STEELCASE	ORANGEBOX SULLY STOOL	N/A		6
F9	SIDE TABLE	N/A	STEELCASE	COALESSE AWAIT TABLE	N/A		5
F10	SOFA	86cm H 142cm W 82cm D	BUY RAINBOW	SOFA 2 SEATER NINA FABRIC NINA-2S-BLU	MVR 5,936.00 (Incl. GST)		2
F11	KIDS FURNITURE	N/A	Y-LIGHTING	The Frank Gehry Furniture Collection, Left Twist Cube	\$250 CAD		6

## GENERAL NOTES

1. Contractor to coordinate with Mechanical/Electrical engineer(s) and Manufacturer on site, to confirm mechanical and electrical requirements and dimensions of equipment before proceeding with any adjacent millwork. Contractor responsible to coordinate all equipment provided by client.
2. Security, telephone, computer, public address systems and music systems are to be supplied by others and installed by contractor. Contractor to provide wire stubs as required. Speaker boxes to be painted out to match adjacent ceiling colour/finish.
3. Contractor to confirm all equipment sizes prior to fabrication of any millwork.
4. All cabinet interiors to have plastic laminate or melamine finish as specified.

## EQUIPMENT SCHEDULE

KEY	DESCRIPTION	DIMENSIONS H x W x D	MANUFACTURER /SUPPLIER	CODE/SERIES	COST	IMAGE	QUANTITY
E1	HAND SANITIZER	700ml	DISPLETECH	9000035 - AUTOMATIC HAND SANITIZING DISPENSER/ DROPP 700ML 9000035	N/A		2
E2	COMPUTER SCREEN	Mounting Base: 3 1/8 x 3" (W x D) Post: 2 x 15 3/8" (Diam x H) Reach: 19"	ULINE	STANDARD DESKTOP MONITOR MOUNT - SINGLE H-7618	\$52 CAD / each		7
E3	PRINTER	64cm H 61cm W 96cm D	MAPLE COPIERS INC	Pre-Owned Ricoh MP 3353 B/W Multi-function Copy/Print/Scan/Fa x 2 Trays Copier	\$1,750.00 CAD		2
E4	STOVE RANGE (GAS HOB)	5.2cm H 59cm W 52cm D	BUY RAINBOW	FAGOR BUILT-IN GAS HOB 3 BURNERS BLACK GLASS (3CFI-3GLSTB) 21051	MVR 4,717.00 (Incl. GST)		1
E5	DISHWASHER	82cm H 45cm W 55cm D	BUY RAINBOW	SMEG FULLY INTEGRATED DISHWASHER STA4529IN	MVR 20,617.00 (Incl. GST)		1
E6	FRIDGE	144cm H 54.5cm W 57.1cm D	BUY RAINBOW	AMICA FREESTANDING REFRIGERATOR (FD228.3X) 1170425	MVR 7,208.00 (Incl. GST)		1
E7	CONFERENCE ROOM SCREEN MONITOR	70" display	DELL	Dell C70171 70" Interactive Conference Room Touchscreen Monitor 884116233992	\$492 CAD each		4

No.	Description	Date

PROJECT NAME:  
MEERY PROJECT

DRAWING:  
FURNITURE AND EQUIPMENT PLAN


SCALE:  
1/4" = 1'-0"

DRAWN BY:  
LD NK

DRAWING NO.  
ID1.3

DATE:  
SEP 29, 2020

CHECKED BY:  
ZM

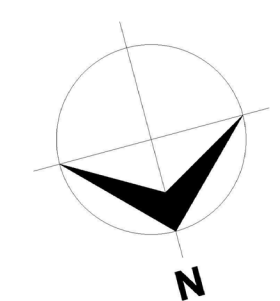

TRUE NORTH