


FIYAVATHI SUPERVISORS ROOM

PROPOSED DESIGN DETAILS

KANEERU MAGU, HULHUMALE

MARCH 2021

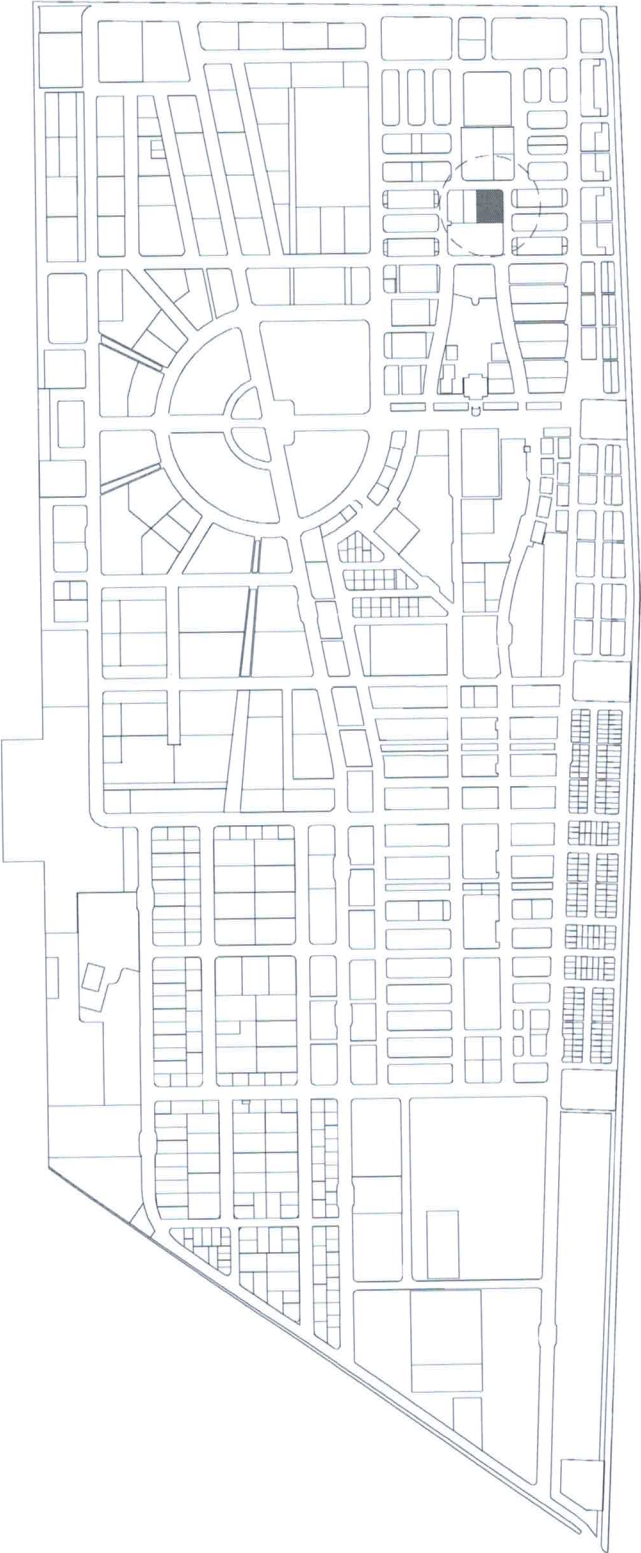

SITE LOCATION
NTS

DRAWN BY: _____

NAZA

15 MARCH 2021

REVISION

NAME

DATE

SCALE:

SHEET NO:

SHEET CONTENT:


SITE LOCATION

PAGE NO:

A01



PROPOSED SUPERVISORS ROOM LOCATION
SCALE 1:100

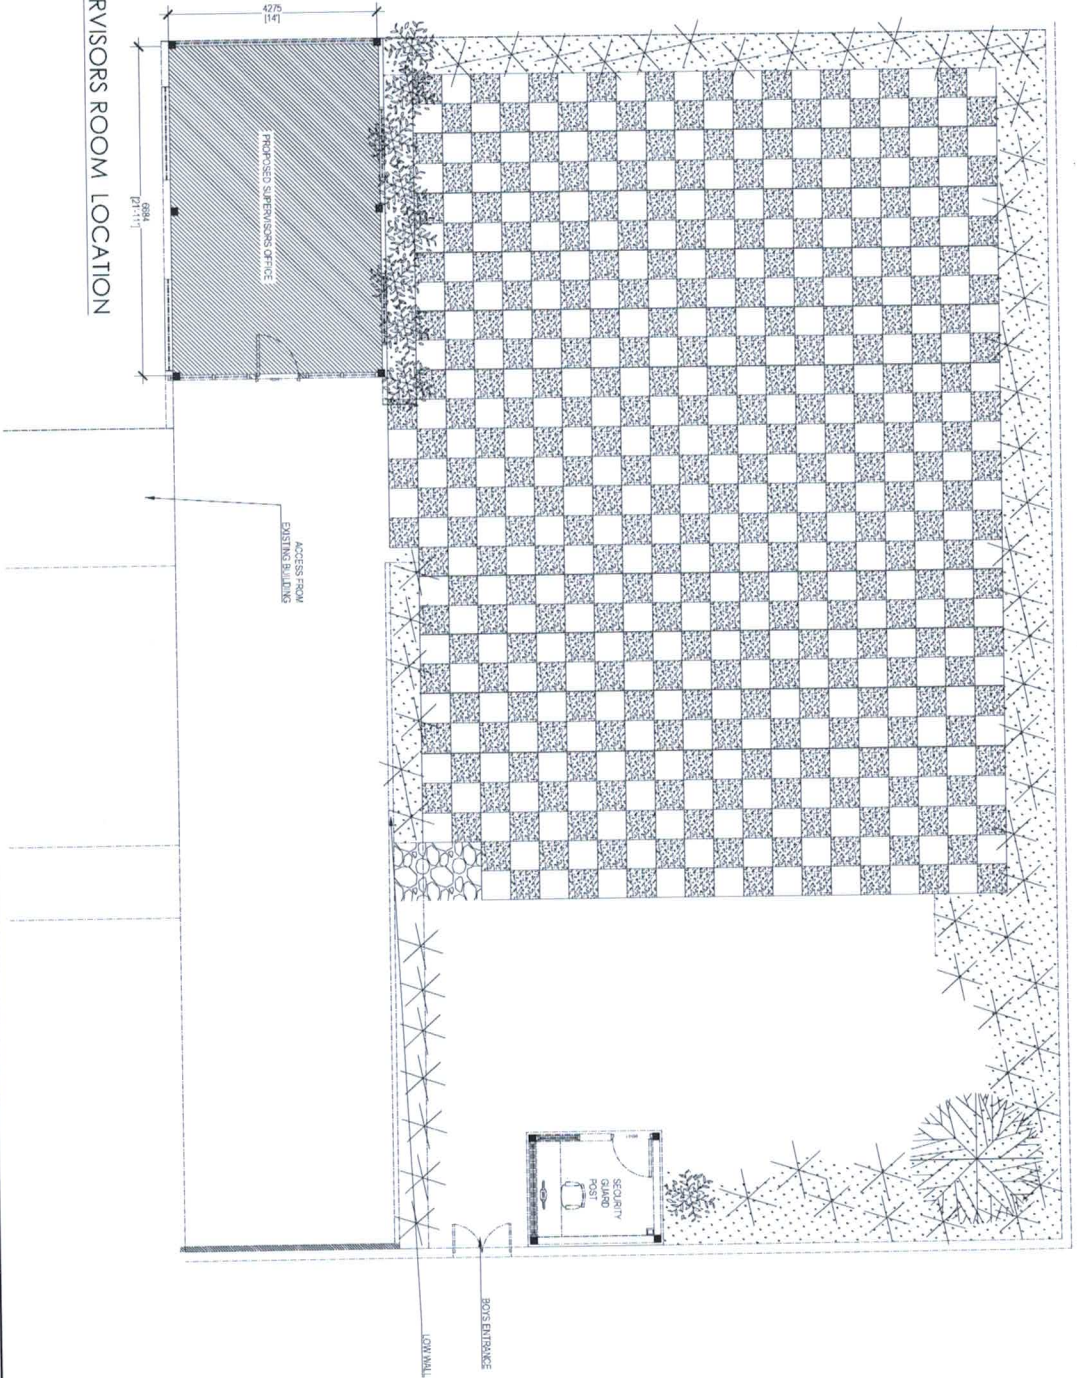

DRAWN BY: NAZA

REVISION: 15 MARCH 2021

NAME: _____ DATE: _____




SCALE: _____ SHEET NO: _____

SHEET CONTENT:

LOCATION PLAN

PAGE NO.

A02

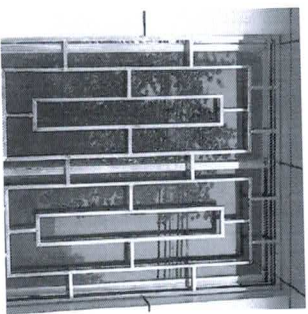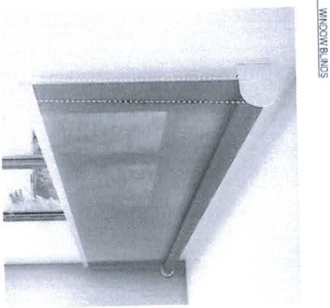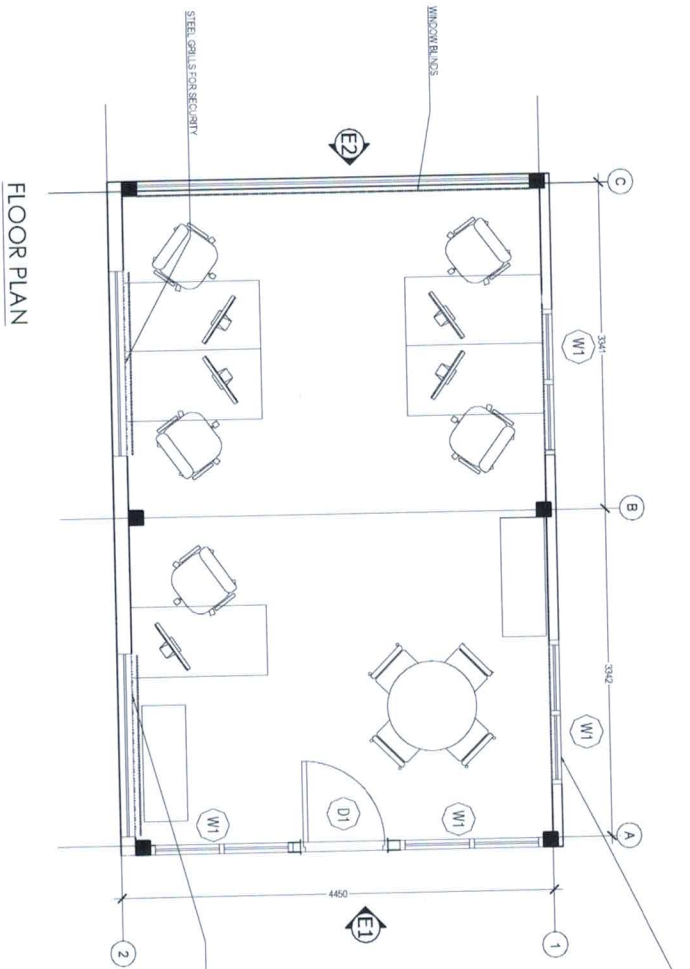

SUPERVISORS ROOM DETAILS
SCALE 1:50


NOTE: ON-SITE MEASUREMENTS REQUIRED BEFORE PROCUREMENT AND FABRICATION OF ALL MATERIALS TO BE INSTALLED. ALL MATERIALS TO BE INSTALLED MUST BE APPROVED BY THE ARCHITECT AND BELONG TO REMAIN AS FITS.

WINDOW BLINDS
STEEL GRILL


DRAWING BY: NAZA	
13 MARCH 2021	
REVISION	DATE
NAME	
SCALE	SHEET NO:

SHEET CONTENT:	
REFERENCE LAYOUT	

PAGE NO.

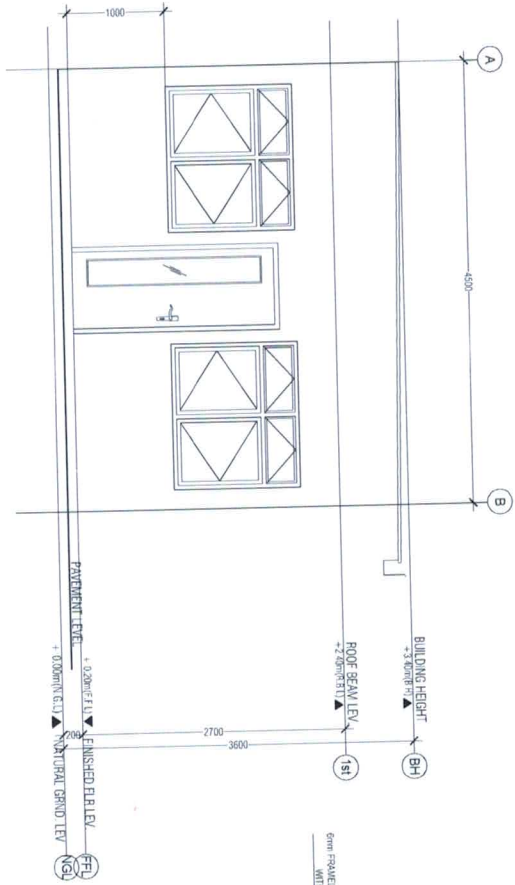

ELEVATION E1

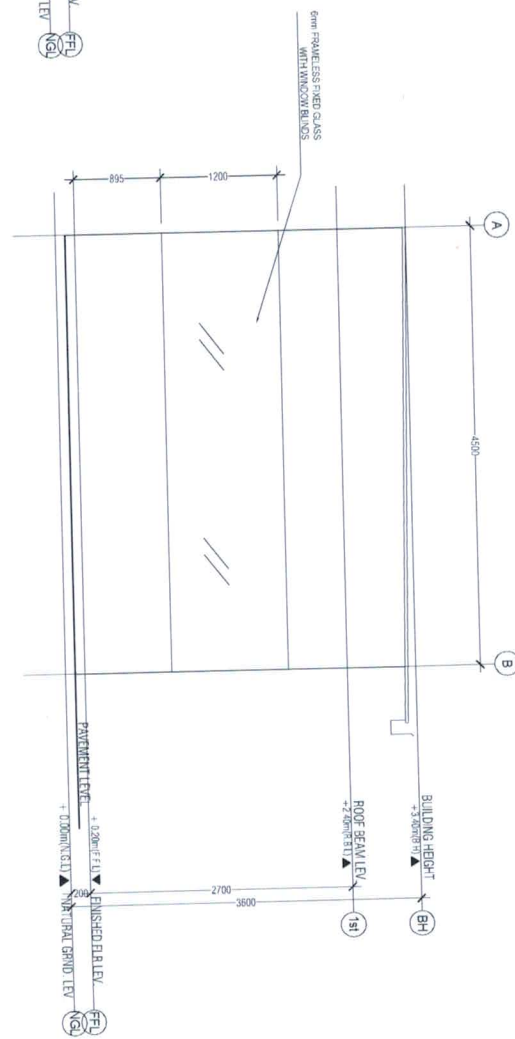


ELEVATION E2

NOTE: ON-SITE MEASUREMENTS REQUIRED BEFORE PROCUREMENT AND FABRICATION OF ALL WALLS TO BE PAINTED WHITE. FLOORING AND CEILING TO REMAIN AS IT IS.

LEGEND:
 WINDOW BLINDS
 STEEL WALL

SUPERVISORS ROOM DETAILS
 SCALE 1:50

DRAWN BY:	NAME:	DATE:	SHEET NO.:
13 MARCH 2021			
SHEET CONTENT:			
SURROUNDING LAYOUT			
PAGE NO.:			
A04			

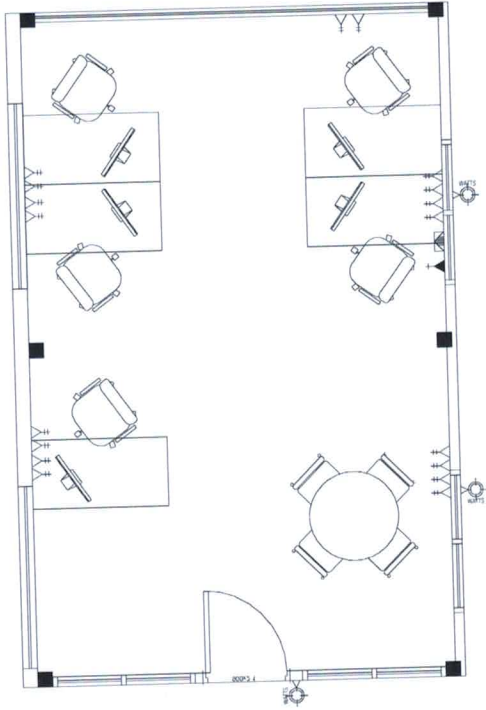

ELECTRICAL PLAN

LEGEND		
SYMBOL	DESCRIPTION	QTY
	OUTDOOR WALL LIGHT	03
	24000 BTU AIR CONDITION	01
	15A POWER OUTLET	01
	20/30A POWER OUTLET	18

NOTE: ON-SITE MEASUREMENTS REQUIRED BEFORE PROCUREMENT AND FABRICATION OF ALL MATERIALS. ALL WORK SHALL BE PERFORMED WHILE RESPONSIBLE FOR THE WORK. ALL WORK SHALL BE PERFORMED WHILE RESPONSIBLE FOR THE WORK.

WINDOW BLINDS
STEEL GRILL

SUPERVISORS ROOM DETAILS
SCALE 1:50

DRAWN BY:	
NANA	
15 MARCH 2021	
REVISION	
NAME	DATE
SCALE:	SHEET NOS:

SHEET CONTENT:	
PLAY AREA DETAILS	

PAGE NO.

A05

PLAN	ELEVATION
<p>Finished Floor Level</p> <p>DOOR WINDOW SYMBOL (NO.)</p> <p>01</p>	<p>WM</p>
<p>FRAME</p> <p>SOLID WOOD</p>	<p>80 MCGON WHITE POWDER COATED ALUMINIUM FRAME</p>
<p>HARDWARE</p> <p>01 NO. GLAZED GLASS PANELS 02 NOS. HINGES 01 NO. STAINLESS STEEL HANDLE 01 NO. LOCK</p>	<p>02 NOS. GLAZED SWIRLING WINDOW PANELS 02 NOS. GLAZED TOP HUNG WINDOW PANELS 06 NOS. HINGES 06 NOS. STAY FRCTION 04 NOS. LOCK HANDLE</p>
<p>GLAZING</p> <p>10MM THICK CLEAR THERMO GLASS</p>	<p>8MM THICK LIGHT GRAY TINTED GLASS</p>
<p>FINISH</p> <p>PAINT FINISH</p>	
<p>QUANTITY</p> <p>01</p>	<p>4</p>

SCHEDULE OF DOORS & WINDOWS 01
SCALE 1:50

DRAWN BY: _____
 DATE: _____
 13 MARCH 2021
 REVISION: _____
 NAME: _____
 DATE: _____
 SCALE: _____
 SHEET NO: _____

SHEET CONTENT: _____

