


ELECTRICAL LAYOUT

SCALE: 1 : 100

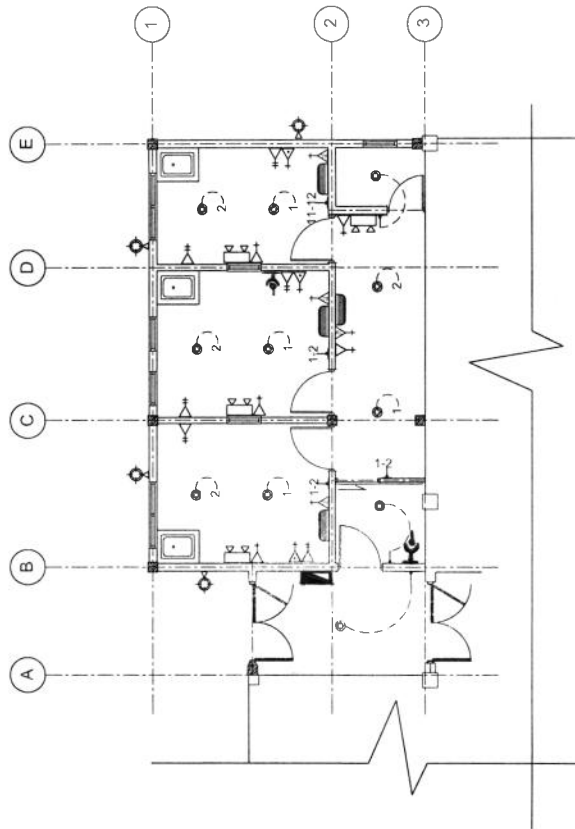

LEGEND

SYMBOL	DESCRIPTION
	LED BULB WITH 200MM DOWN LIGHT
	1 x 13 AMP SOCKET OUTLET (1200MM ABOVE FFL)
	2 x 13 AMP SOCKET OUTLET (1200MM ABOVE FFL)
	1 x 15 AMP SOCKET OUTLET (1200MM ABOVE FFL)
	1 x 15 AMP AC SOCKET OUTLET (200MM BLW. CEILING)
	TWO GANG SWITCH
	ONE WAY SWITCH
	EMERGENCY LIGHT
	DISTRIBUTION BOARD (WALL EMBEDDED)
	AC WALL MOUNT UNIT
	TELEPHONE SOCKET
	NETWORK SOCKET
	NETWORK SWITCH
	PABX

LEGEND

SYMBOL	DESCRIPTION
	1 x 13 AMP SOCKET OUTLET (200MM BELOW CEILING)
	WALL MOUNT FAN
	FAN REGULATOR
	SW BULB WITH COVERED
	CEILING FAN 1200MM DIA.
	AC INDOOR UNIT, CEILING CASSETTE TYPE
	OUTDOOR LIGHT
	AC OUT DOOR UNIT
	METER WITH OUT DOOR WATER PROOF BOX WITH TRANSPARENT FRONT DOOR

SHEET CONTENTS :

REVISION NOTES

PROJECT
EXTENSION OF PCR
LAB AT URH

CLIENT:

MINISTRY OF HEALTH

LOCATION

R. UNGOOFARAU

CONTENTS : AS GIVEN

PROJECT MANAGER:

DESIGNER: ARIZ

CIVILSTR. ENGINEER:

SURVEYED BY :

DRAWN BY : ARIZ

CHECKED BY :

DATE : JUNE 2021

SHEET NO. :

PAPER SIZE: A3



ADINA DITJAN
Rencana & Konstruksi
Sistem Mekanik
Tel: 812 8857, Fax: 855889