



BANK OF MALDIVES SELF SERVICE ATM BOOTH
LAAMU MAAMENDHOO
CONSTRUCTION DRAWINGS

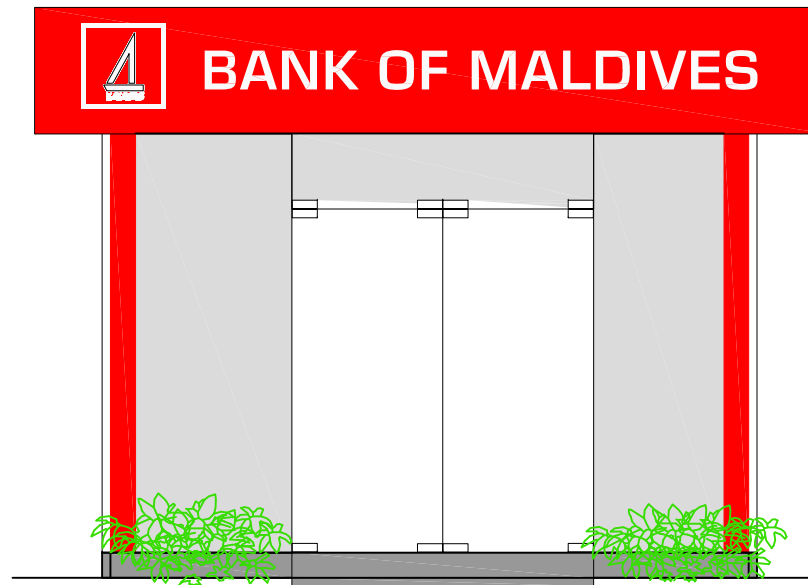

FRONT ELEVATION

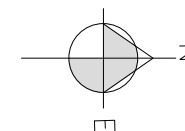



BML ATM BOOTH
LAAMU MAAMENDHOO

SITE PLAN

BML PLC

DESIGN BY	MY		
DRAWN BY	MY		
CHECKED			
DATE	MAY 2021		DWG NO
SCALE			A-01/13
PROJECT NO			

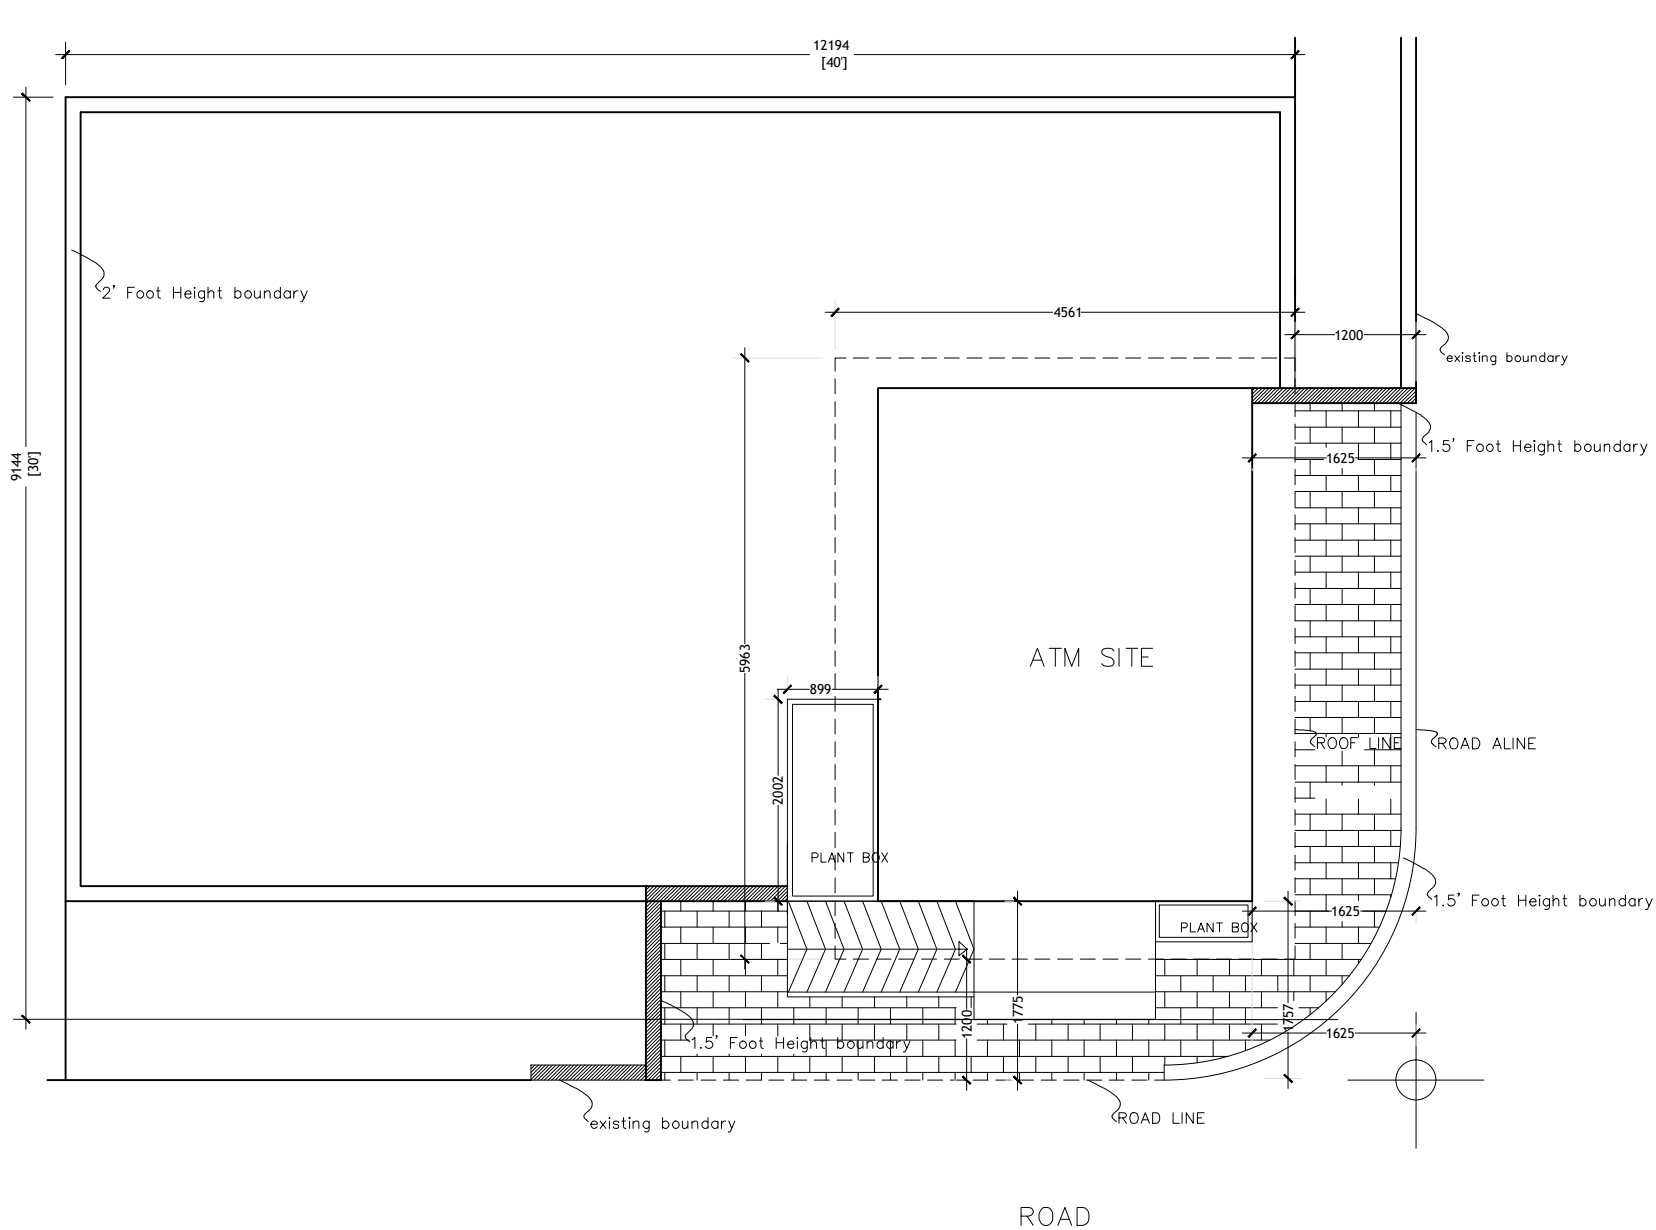


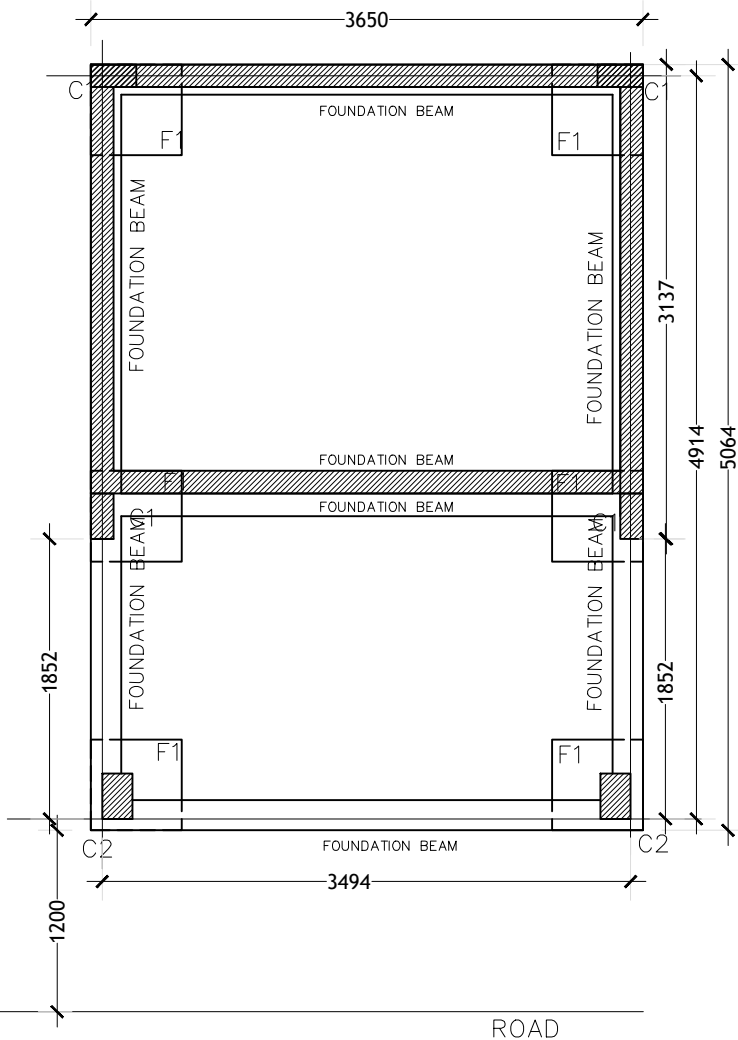

FOUNDATION PLAN
SCALE: 1:50

NOTE:

FOUNDATION DEPTH = 750MM FROM GROUND LVL

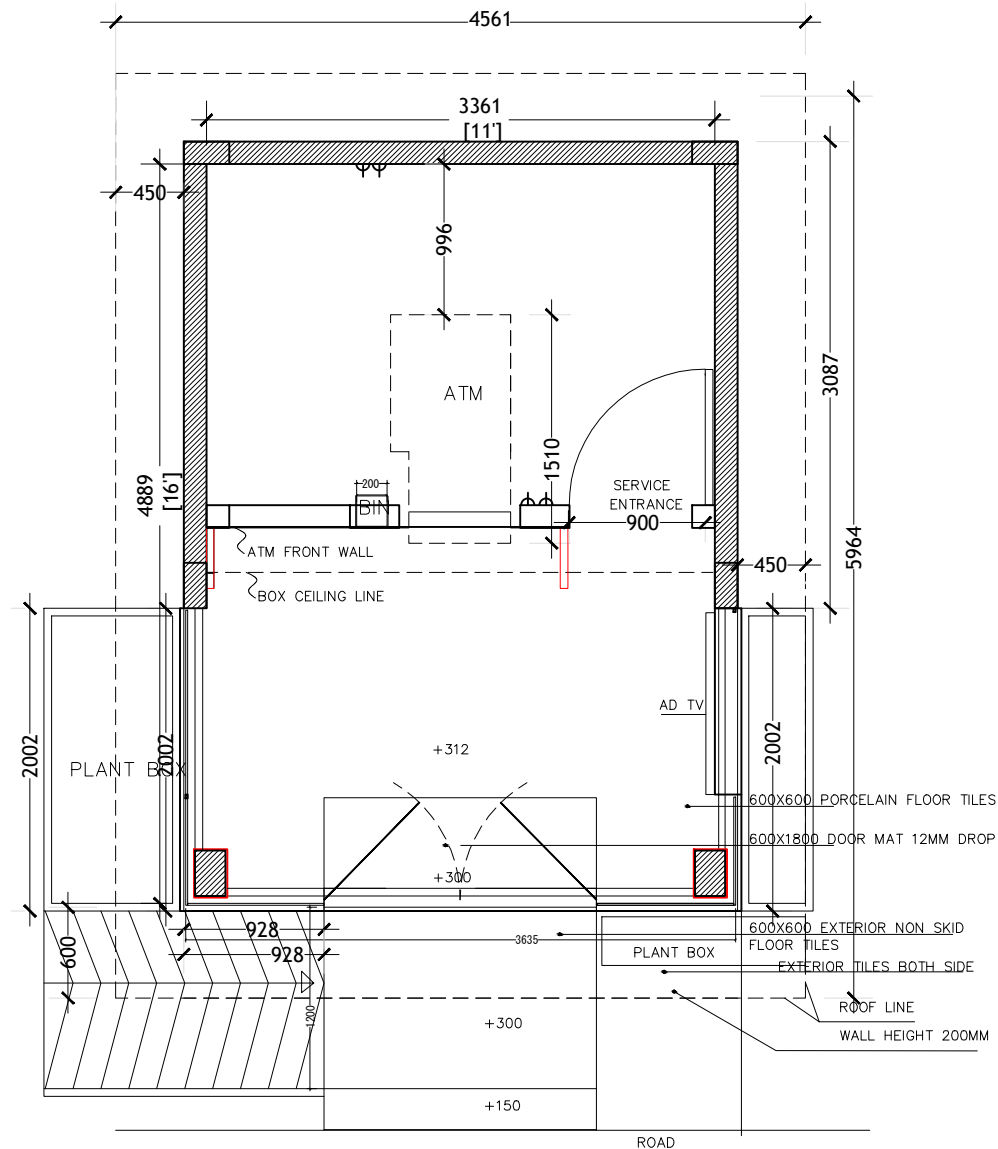

FLOOR PLAN
SCALE: 1:50

IF IN DOUBT - ASK - DO NOT SCALE

PROJECT :

BML ATM BOOTH
LAAMU MAAMENDHOO


TITLE :

FLOOR PLAN
FOUNDATION PLAN

CLIENT :


BML PLC

DESIGN BY	MY	
DRAWN BY	MY	
CHECKED		
DATE	MAY 2021	DWG No
SCALE	1:50	
PROJECT No		A-02/13

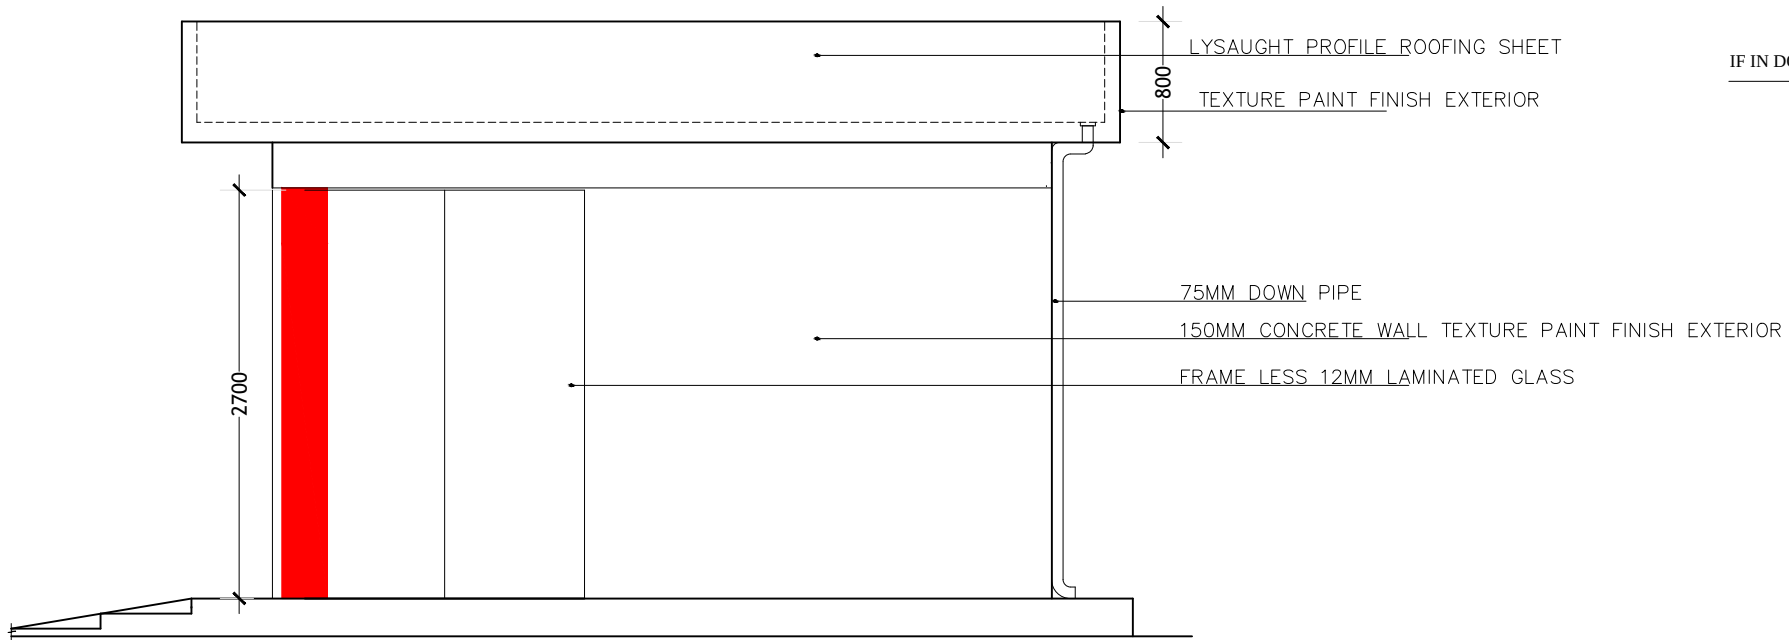

SIDE ELEVATION
SCALE: 1:50

IF IN DOUBT - ASK - DO NOT SCALE

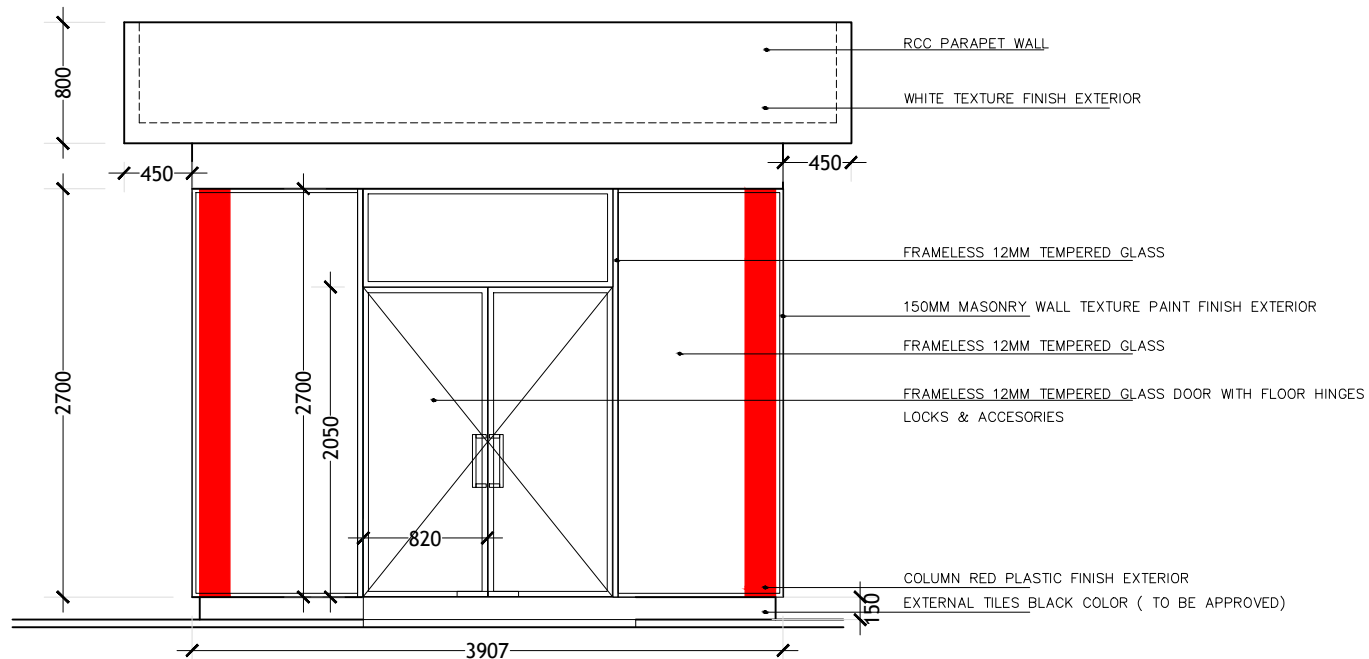

FRONT ELEVATION
SCALE: 1:50

PROJECT :

BML ATM BOOTH
LAAMU MAAMENDHOO

TITLE :


FRNT ELEVATION
SIDE ELEVATION

CLIENT :

BML PLC

DESIGN BY	MY	
DRAWN BY	MY	
CHECKED		
DATE	MAY 2021	DWG No
SCALE	1:50	A-03/13
PROJECT No		

IF IN DOUBT - ASK - DO NOT SCALE

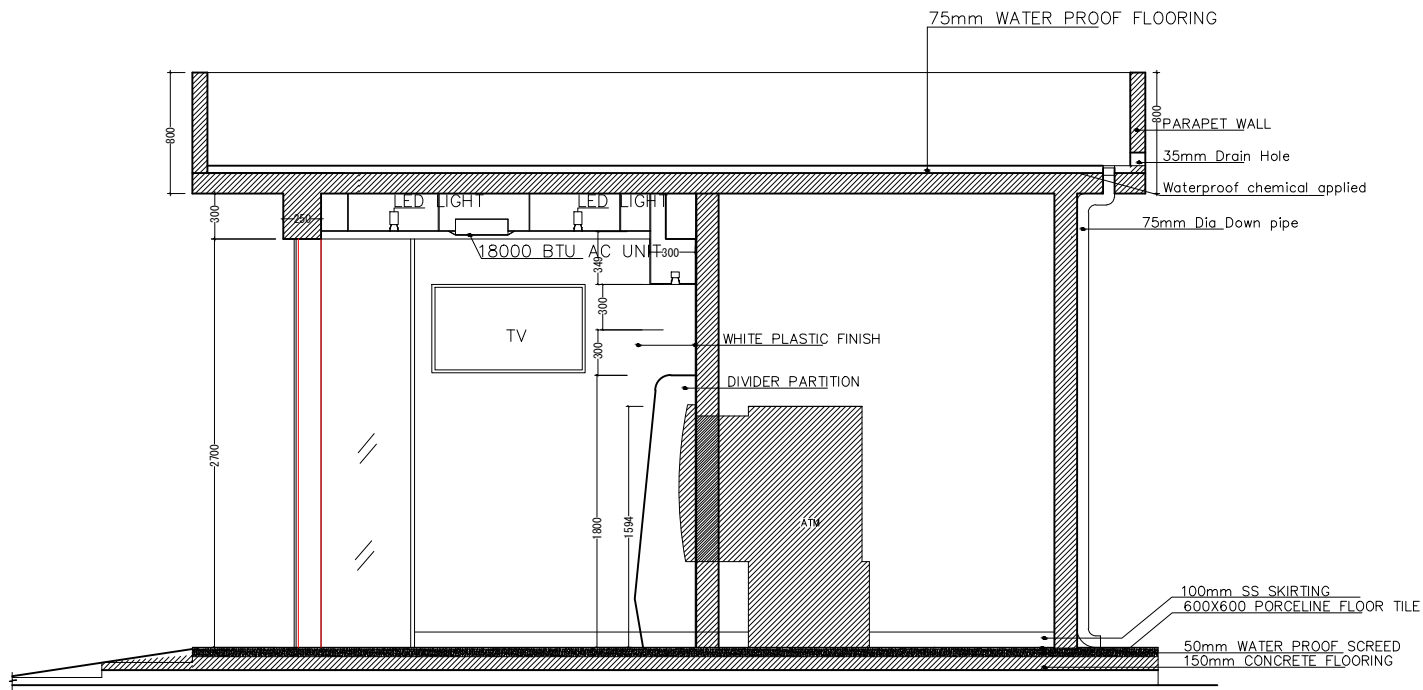

SECTION -A
SCALE: 1:50

PROJECT :

BML ATM BOOTH
LAAMU MAAMENDHOO


TITLE :

SECTION A

CLIENT :

BML PLC


DESIGN BY	MY	
DRAWN BY	MY	
CHECKED		
DATE	MAY 2021	DWG No
SCALE	1:50	A- 04/13
PROJECT No		

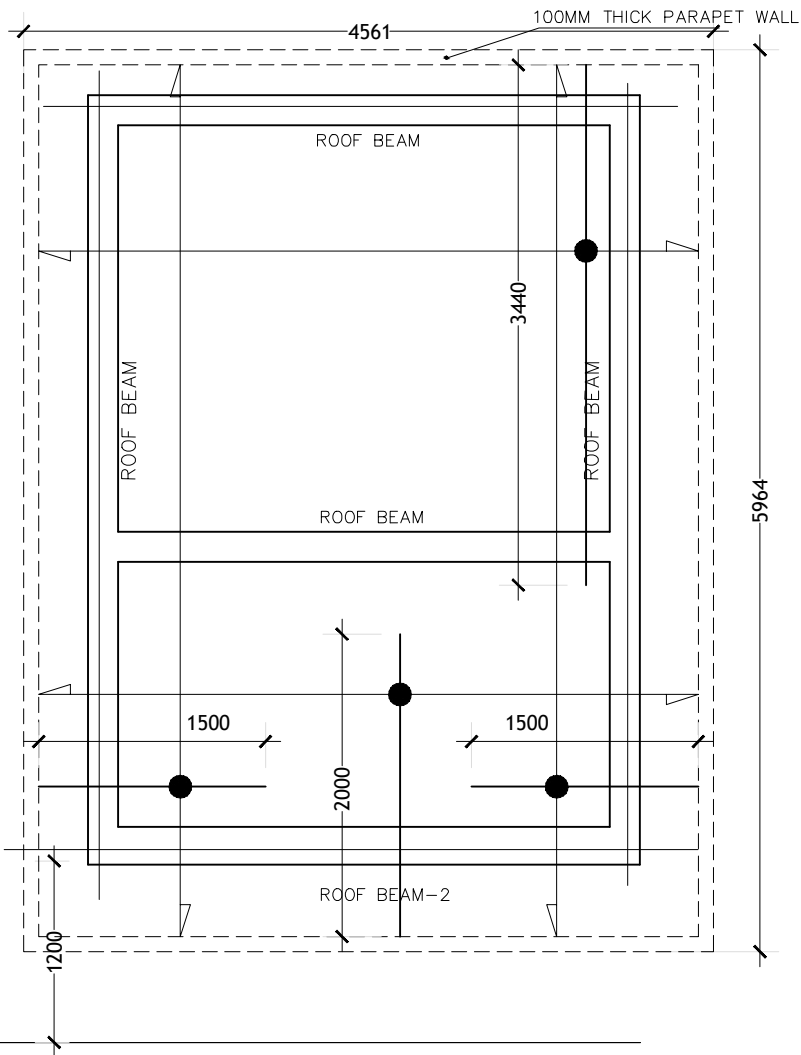

ROOF REINFORCEMENT PLAN
SCALE: 1:50

NOTE

TOP REINFORCEMENT : T10@150 C/C BW (SHOWN)
BOTTOM REINFORCEMENT : T10@150 C/C BW (NOT SHOWN)

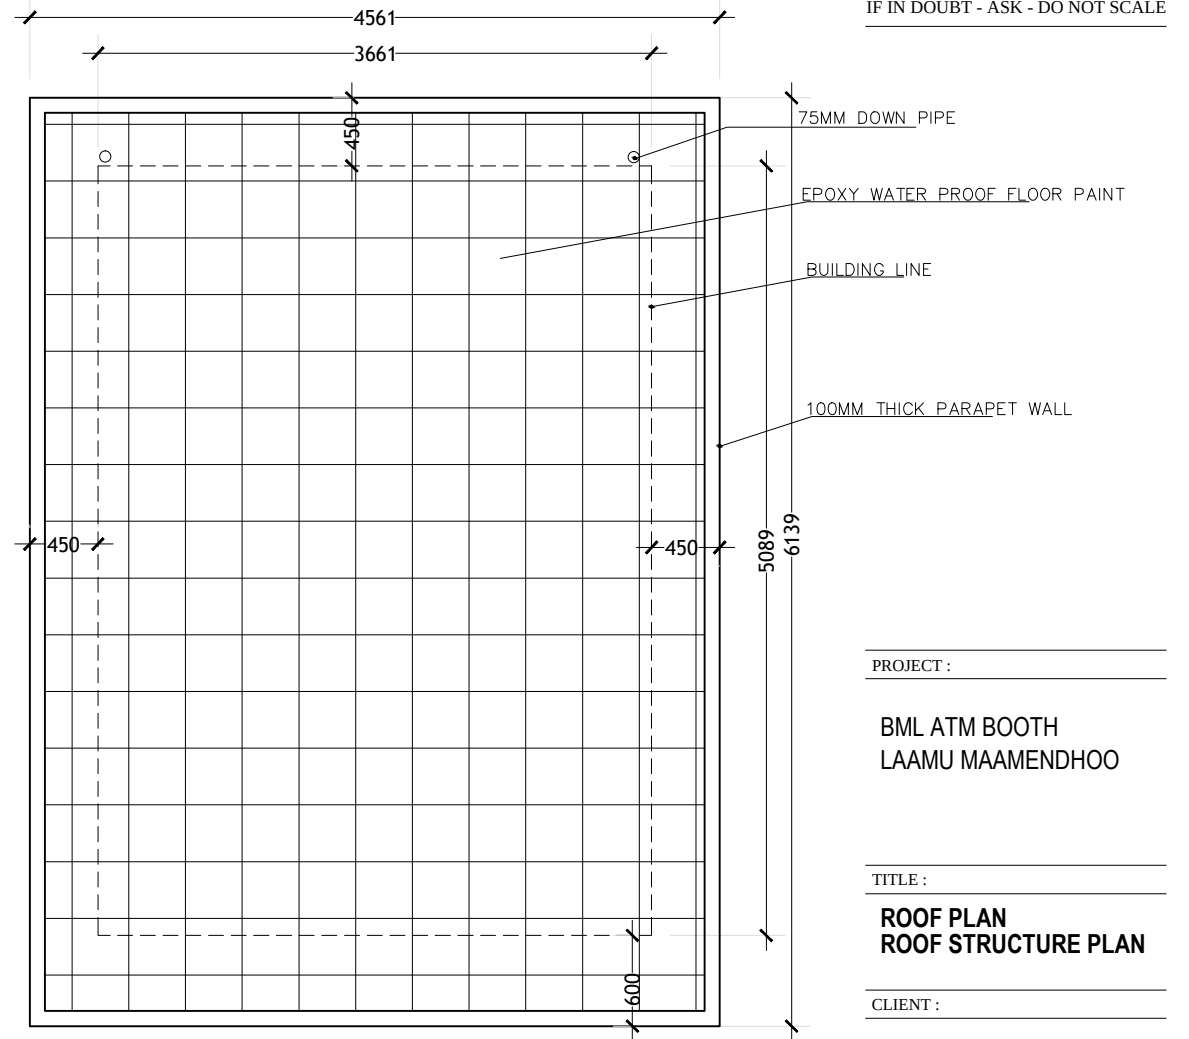

ROOF PLAN
SCALE: 1:50

IF IN DOUBT - ASK - DO NOT SCALE

PROJECT :

BML ATM BOOTH
LAAMU MAAMENDHOO

TITLE :


ROOF PLAN
ROOF STRUCTURE PLAN

CLIENT :

BML PLC


DESIGN BY	MY	
DRAWN BY	MY	
CHECKED		
DATE	MAY 2021	DWG No
SCALE	1:50	A-05/13
PROJECT No		

IF IN DOUBT - ASK - DO NOT SCALE

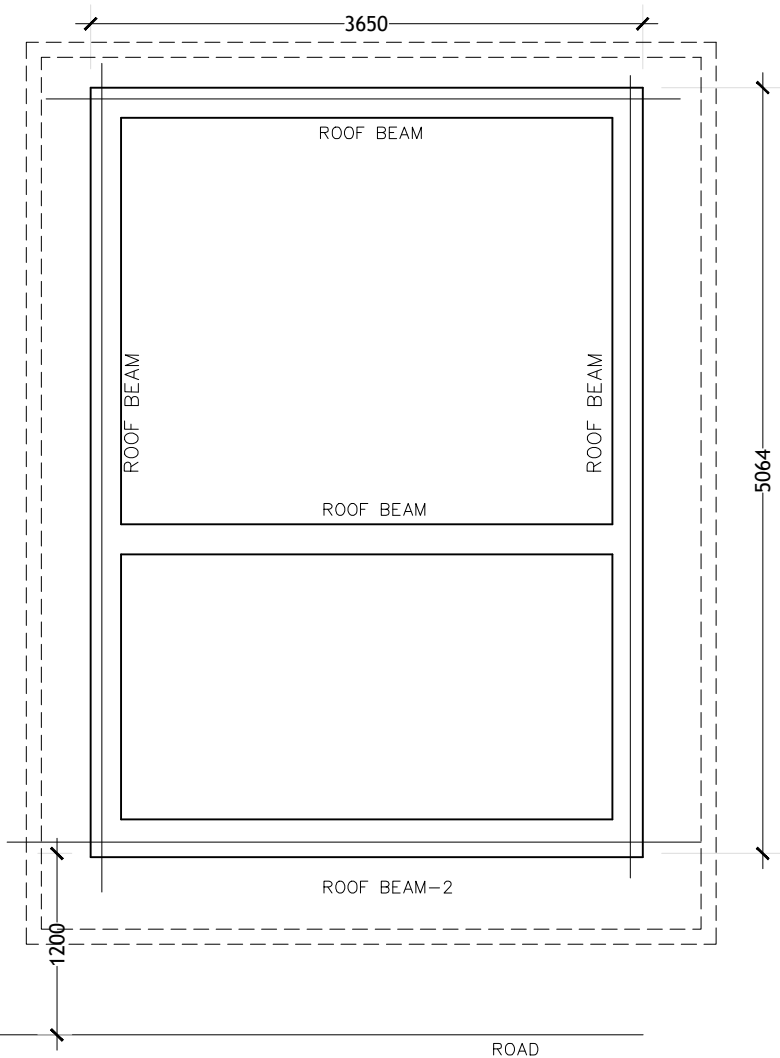

ROOF BEAM PLAN
SCALE: 1:50

NOTE:
GUTTER SLAB THICKNESS = 135MM

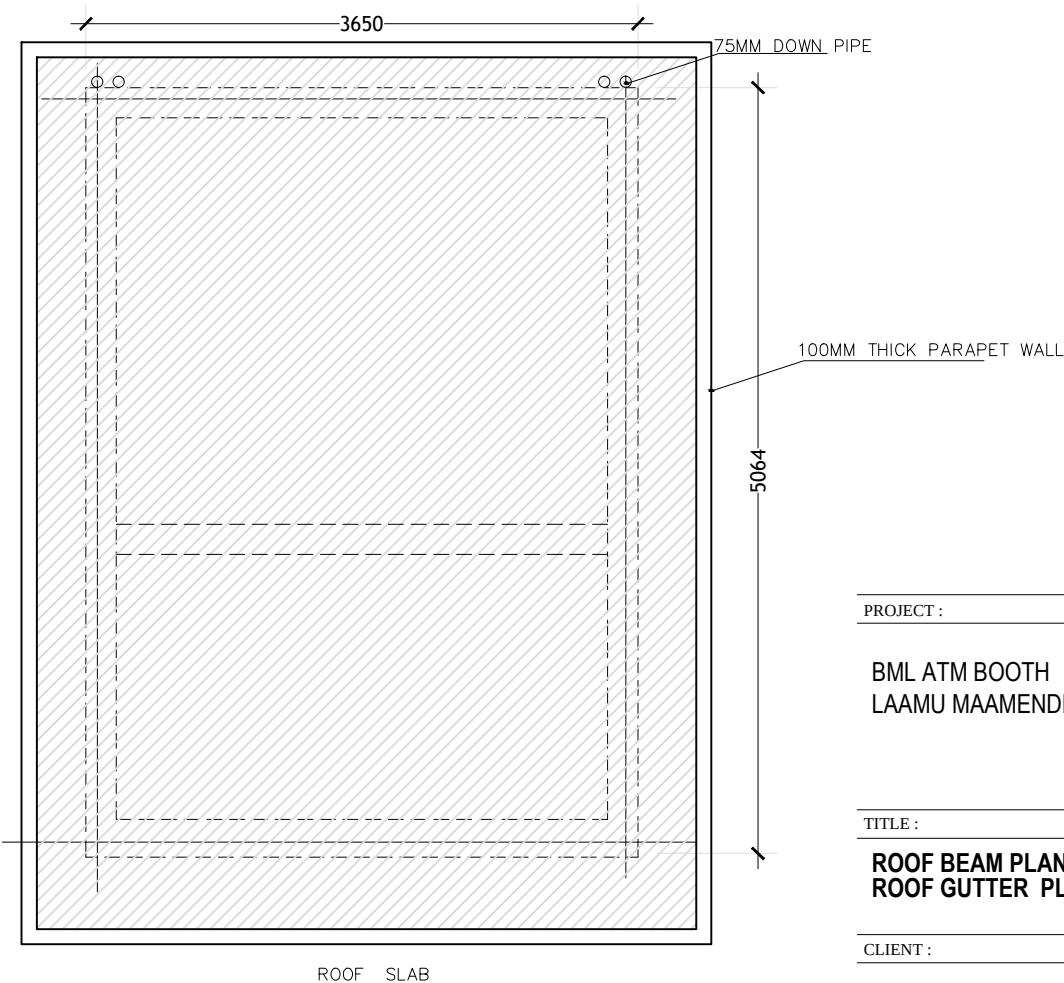

ROOF SLAB PLAN
SCALE: 1:50

PROJECT :

BML ATM BOOTH
LAAMU MAAMENDHOO


TITLE :

ROOF BEAM PLAN
ROOF GUTTER PLAN

CLIENT :


BML PLC

DESIGN BY	MY	
DRAWN BY	MY	
CHECKED		
DATE	MAY 2021	DWG No
SCALE	1:50	A-06/13
PROJECT No		

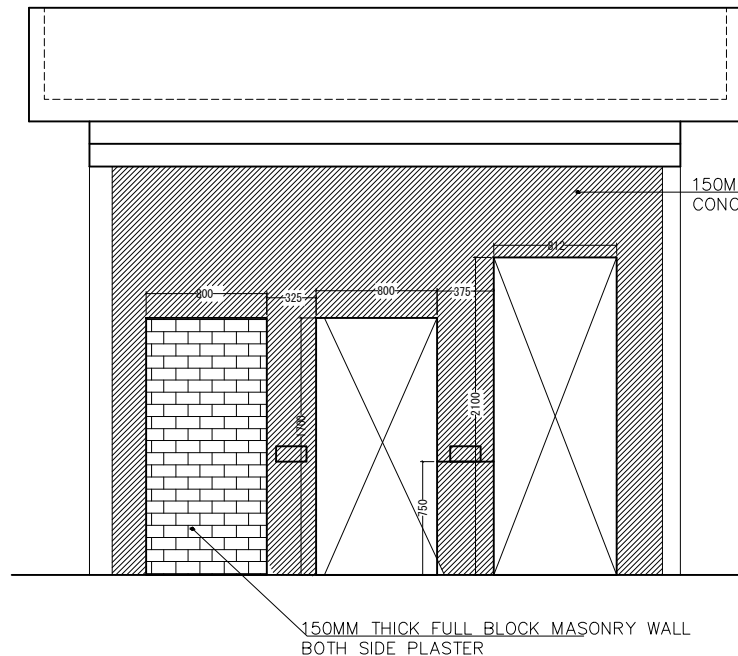

ATM ROOM FRONT WALL
SCALE: 1:50

NOTE:
3 SIDE CONCRETE WALL
FRONT WALL AS PER THE ELEVATION SHOWN
TOP 150MM THICK CONCRETE 27.75 SQM
FLOOR 150MM THICK CONCRETE 18.75SQM

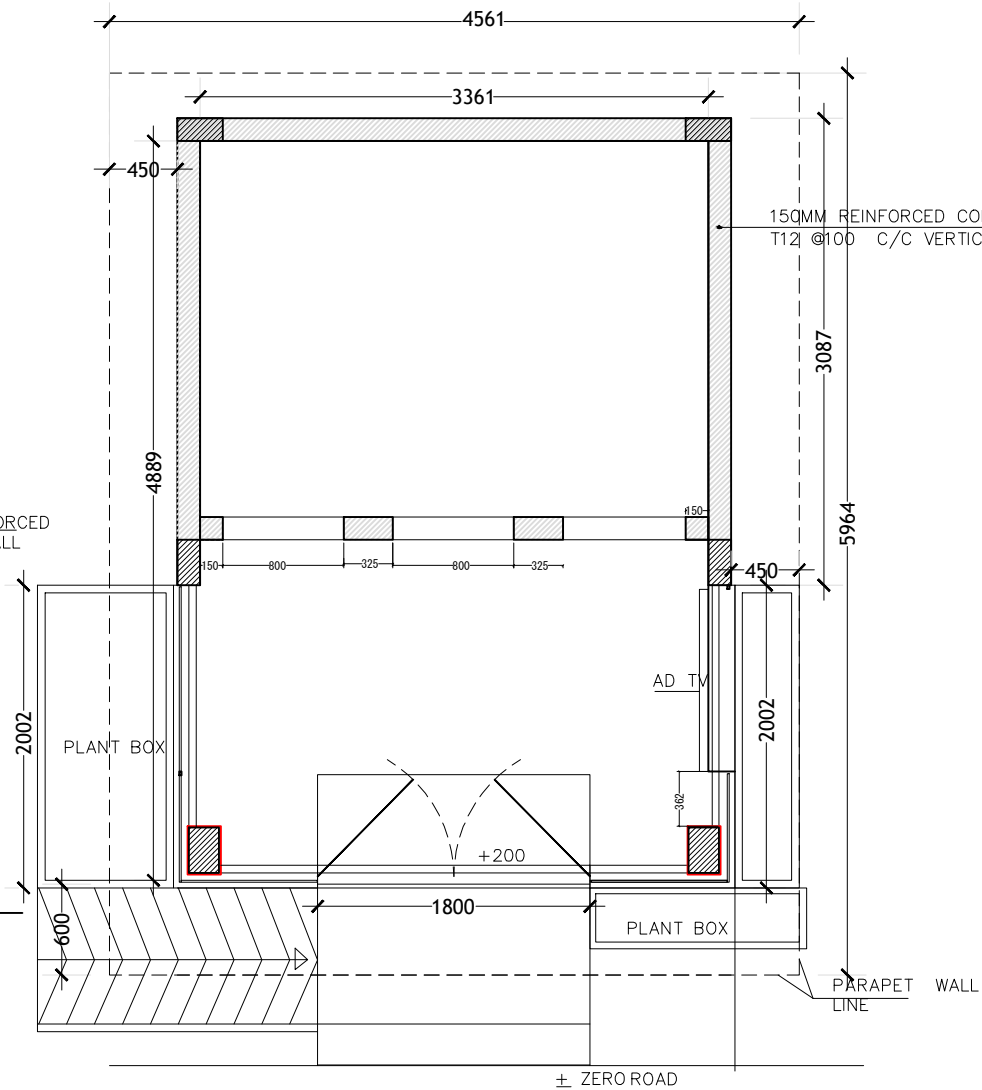

FLOOR PLAN
SCALE: 1:50

IF IN DOUBT - ASK - DO NOT SCALE

PROJECT :

BML ATM BOOTH
LAAMU MAAMENDHOO


TITLE :

FLOOR PLAN

CLIENT :

BML PLC

DESIGN BY	MY	
DRAWN BY	MY	
CHECKED		
DATE	MAY 2021	DWG No
SCALE	1:50	A-07/13
PROJECT No		

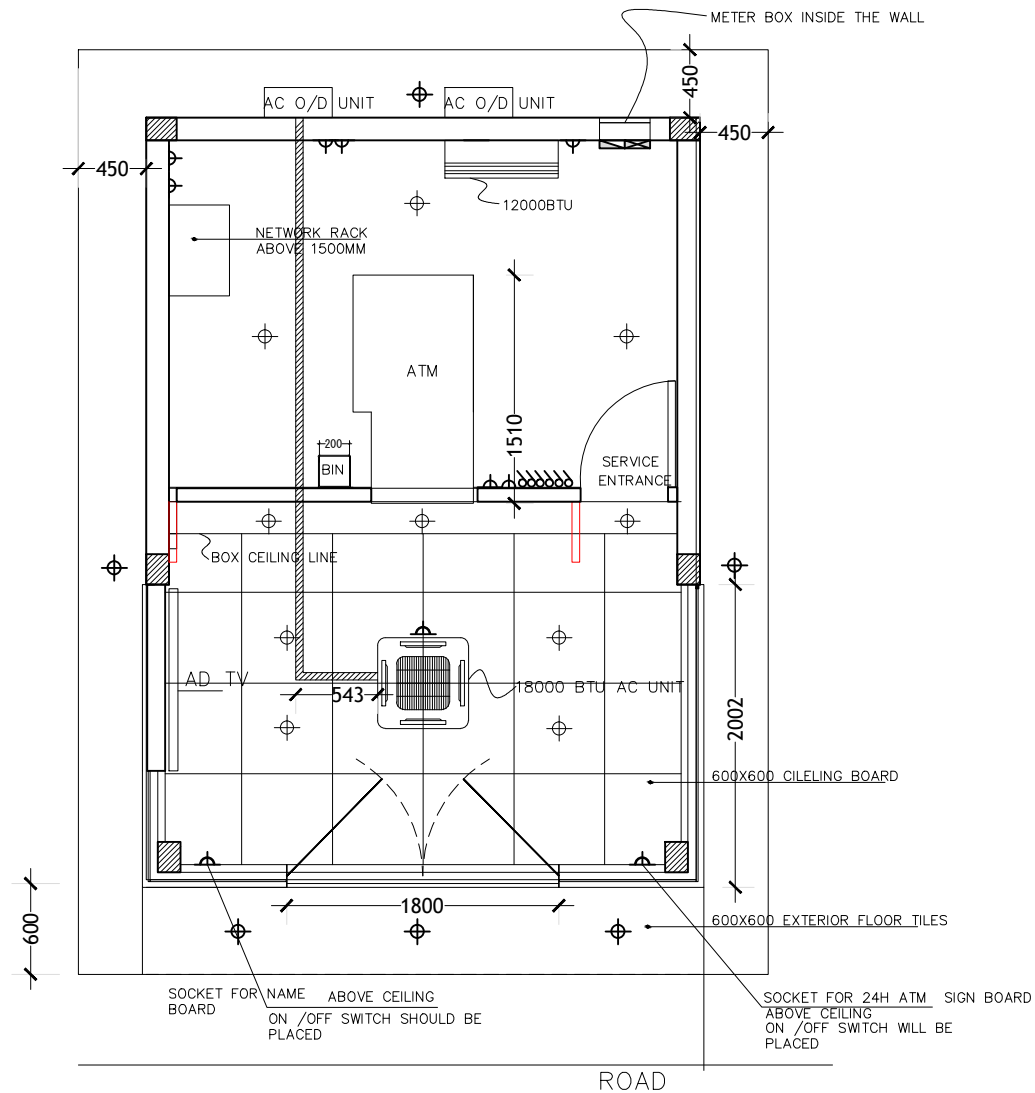

-  SPLIT TYPE INVERTER AIR CONDITION
-  CEILING CASSETTE INVERTER AIR CONDITION
-  3PH HOUSE METER & EXTERNAL DB
-  DISTRIBUTION BOX
-  1GANG 16AMP SOCKETS FOR AC
-  SWITCHES
-  2GANG 13AMP SOCKETS
-  CEILING RECESS OUTDOOR LED LIGHT 15WATT
-  CEILING RECESS LED LIGHT 15WATT

PROJECT :

BML ATM BOOTH
LAAMU MAAMENDHOO

TITLE :

ELECTRICAL PLAN


CLIENT :

BML PLC

DESIGN BY	MY	
DRAWN BY	MY	
CHECKED		
DATE	MAY 2021	DWG No
SCALE	1:50	A-08/13
PROJECT No		


FLOOR PLAN
SCALE: 1:50

IF IN DOUBT - ASK - DO NOT SCALE

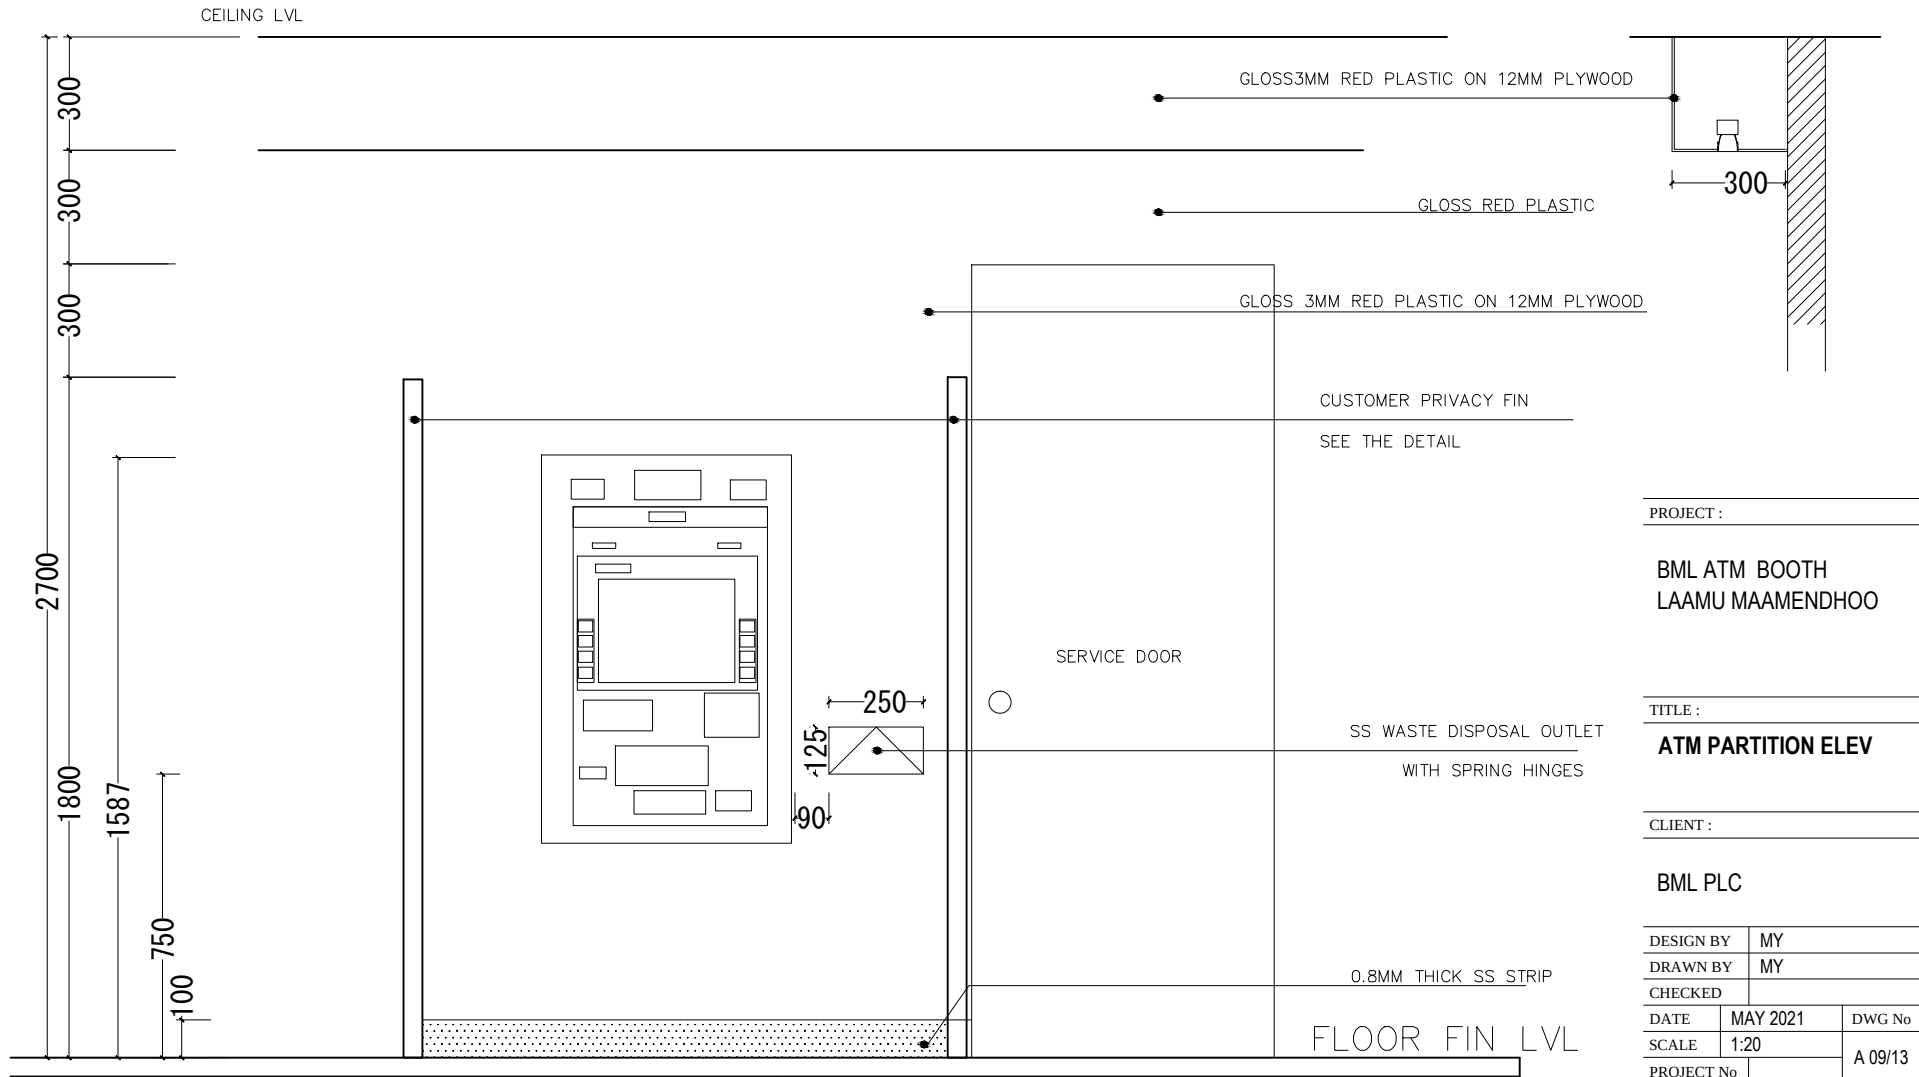

EVEVATION - E1
SCALE 1:20

IF IN DOUBT - ASK - DO NOT SCALE

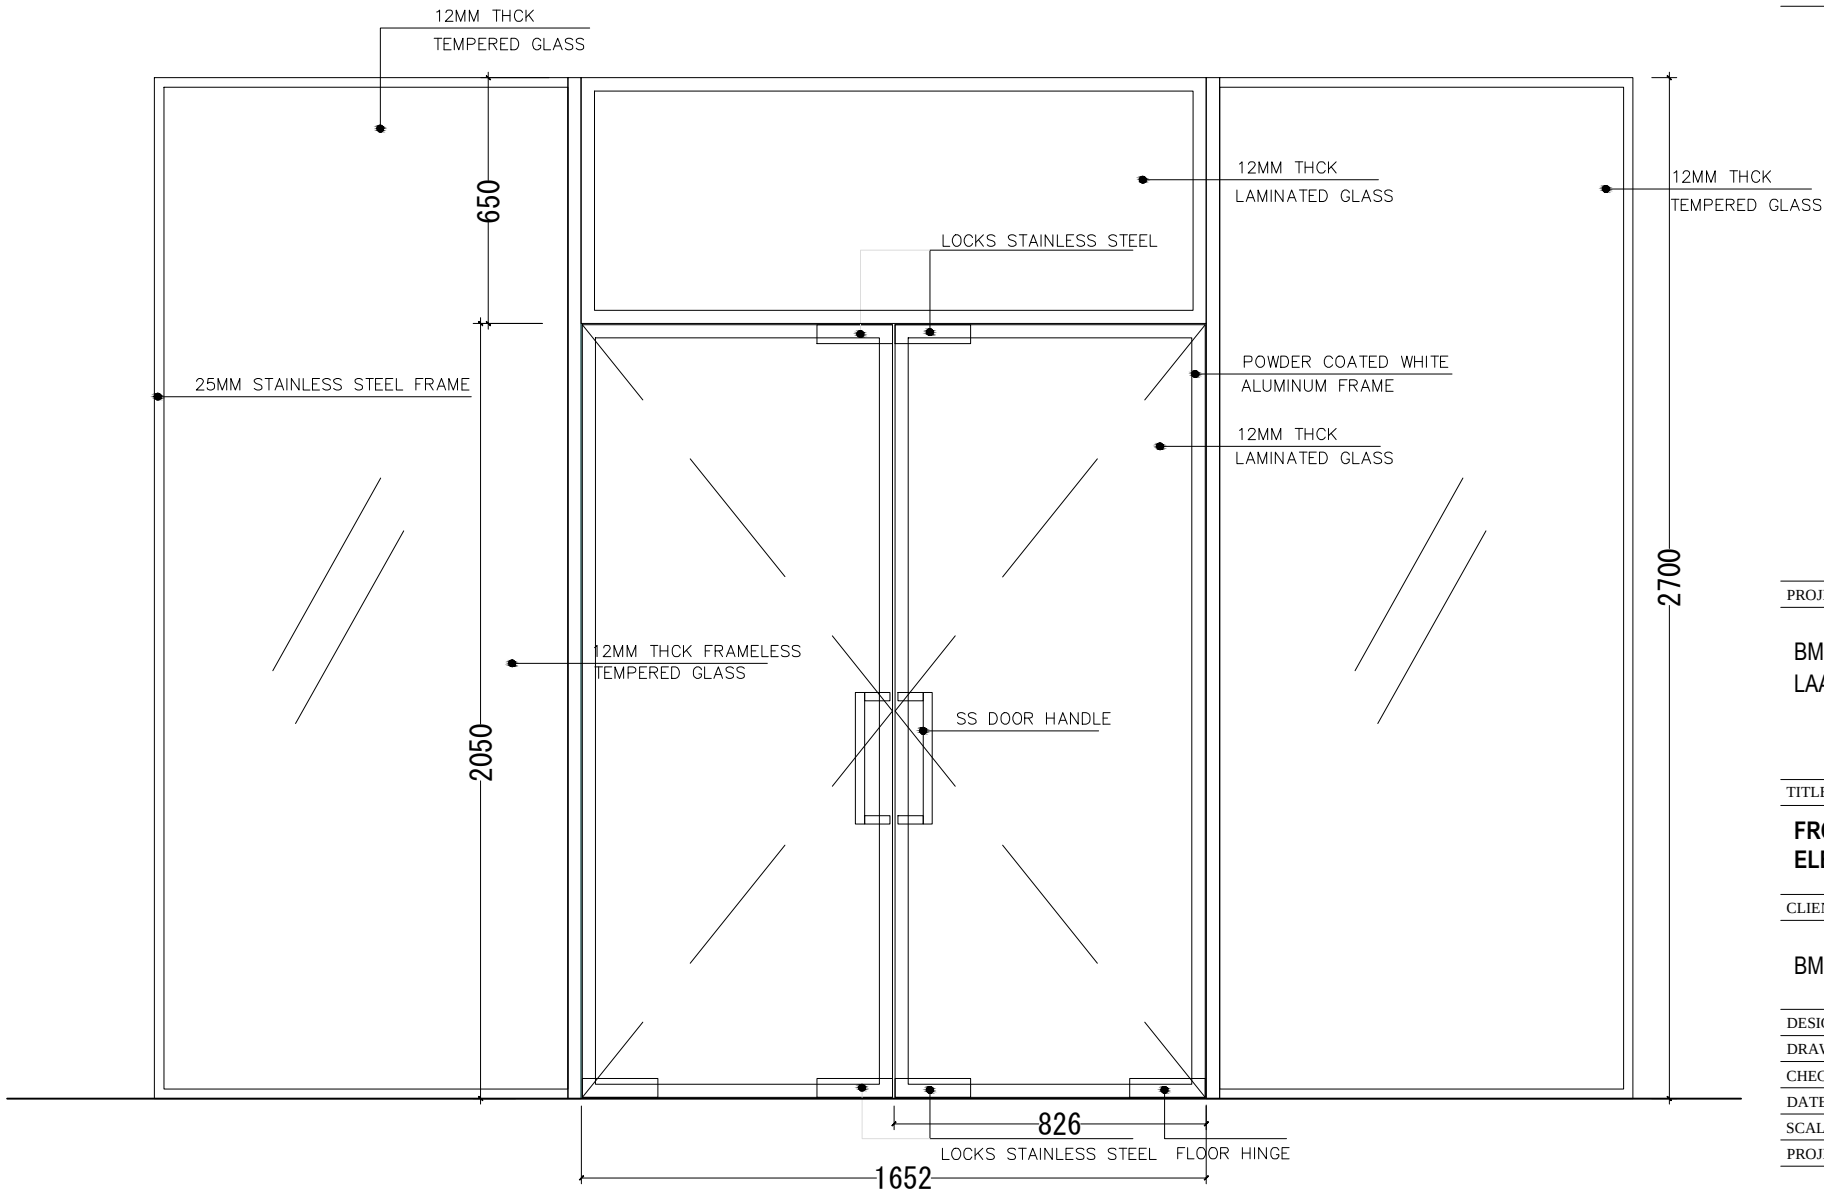

PROJECT :

BML ATM BOOTH
LAAMU MAAMENDHOO

TITLE :



FRONT GLASS & DOOR
ELEV

CLIENT :


BML PLC

DESIGN BY	MY	
DRAWN BY	MY	
CHECKED		
DATE	MAY 2021	DWG No
SCALE	1:20	A 10/13
PROJECT No		


IF IN DOUBT - ASK - DO NOT SCALE

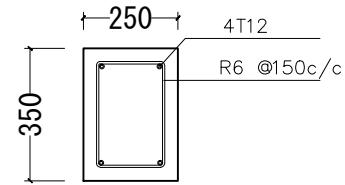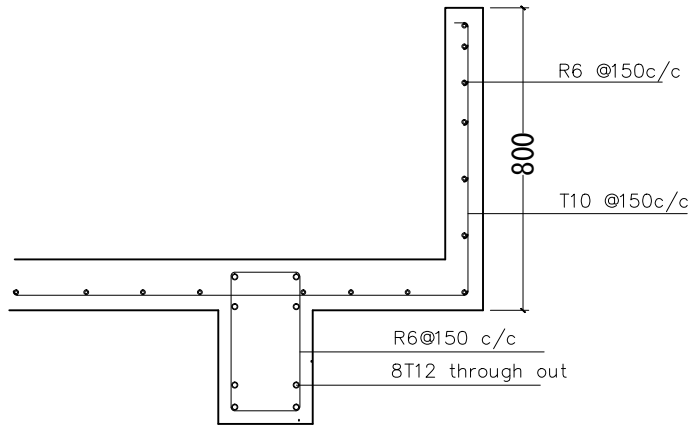


FOUNDATION BEAM

 


COLUMN
(C -1)

 

COLUMN
(C -2)

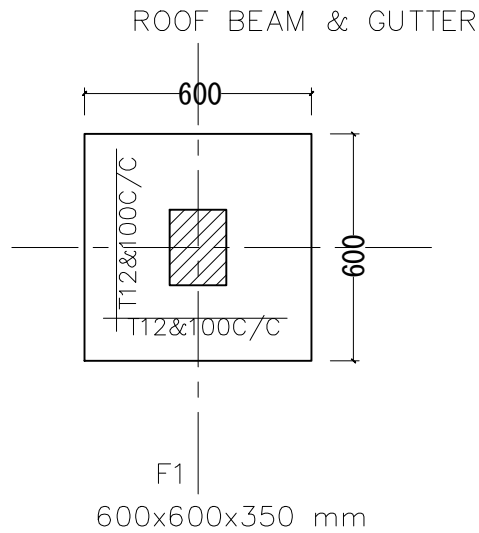

STRUCTURAL DETAIL

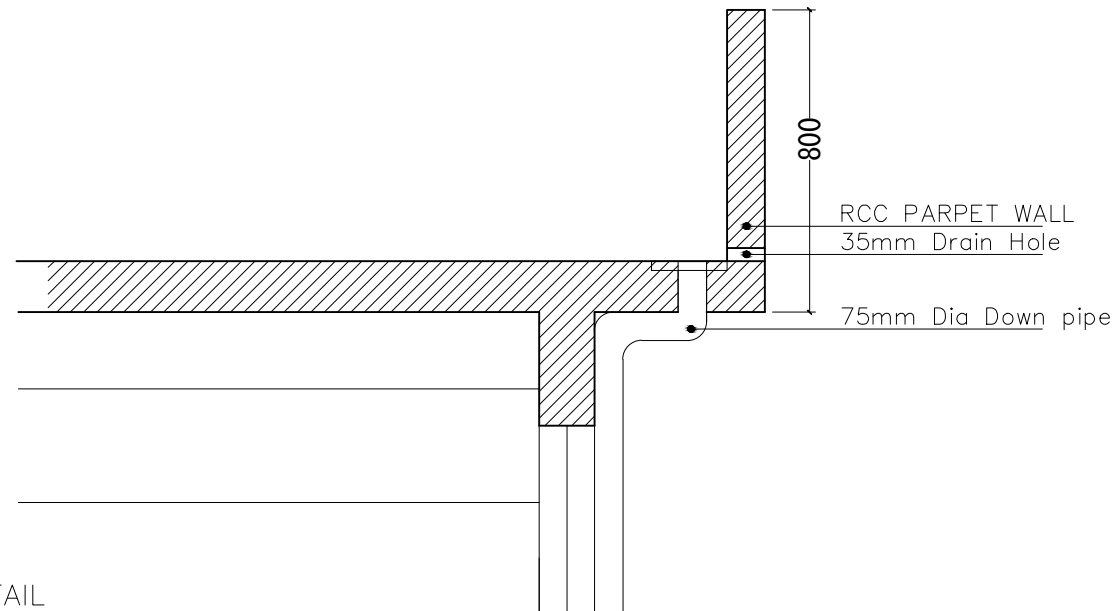

PROJECT :

BML ATM BOOTH
LAAMU MAAMENDHOO

TITLE :


STRUCTURAL DETAILS

CLIENT :

BML PLC

DESIGN BY	MY	
DRAWN BY	MY	
CHECKED		
DATE	MAY 2021	DWG No
SCALE	1:20	A 11/13
PROJECT No		

IF IN DOUBT - ASK - DO NOT SCALE

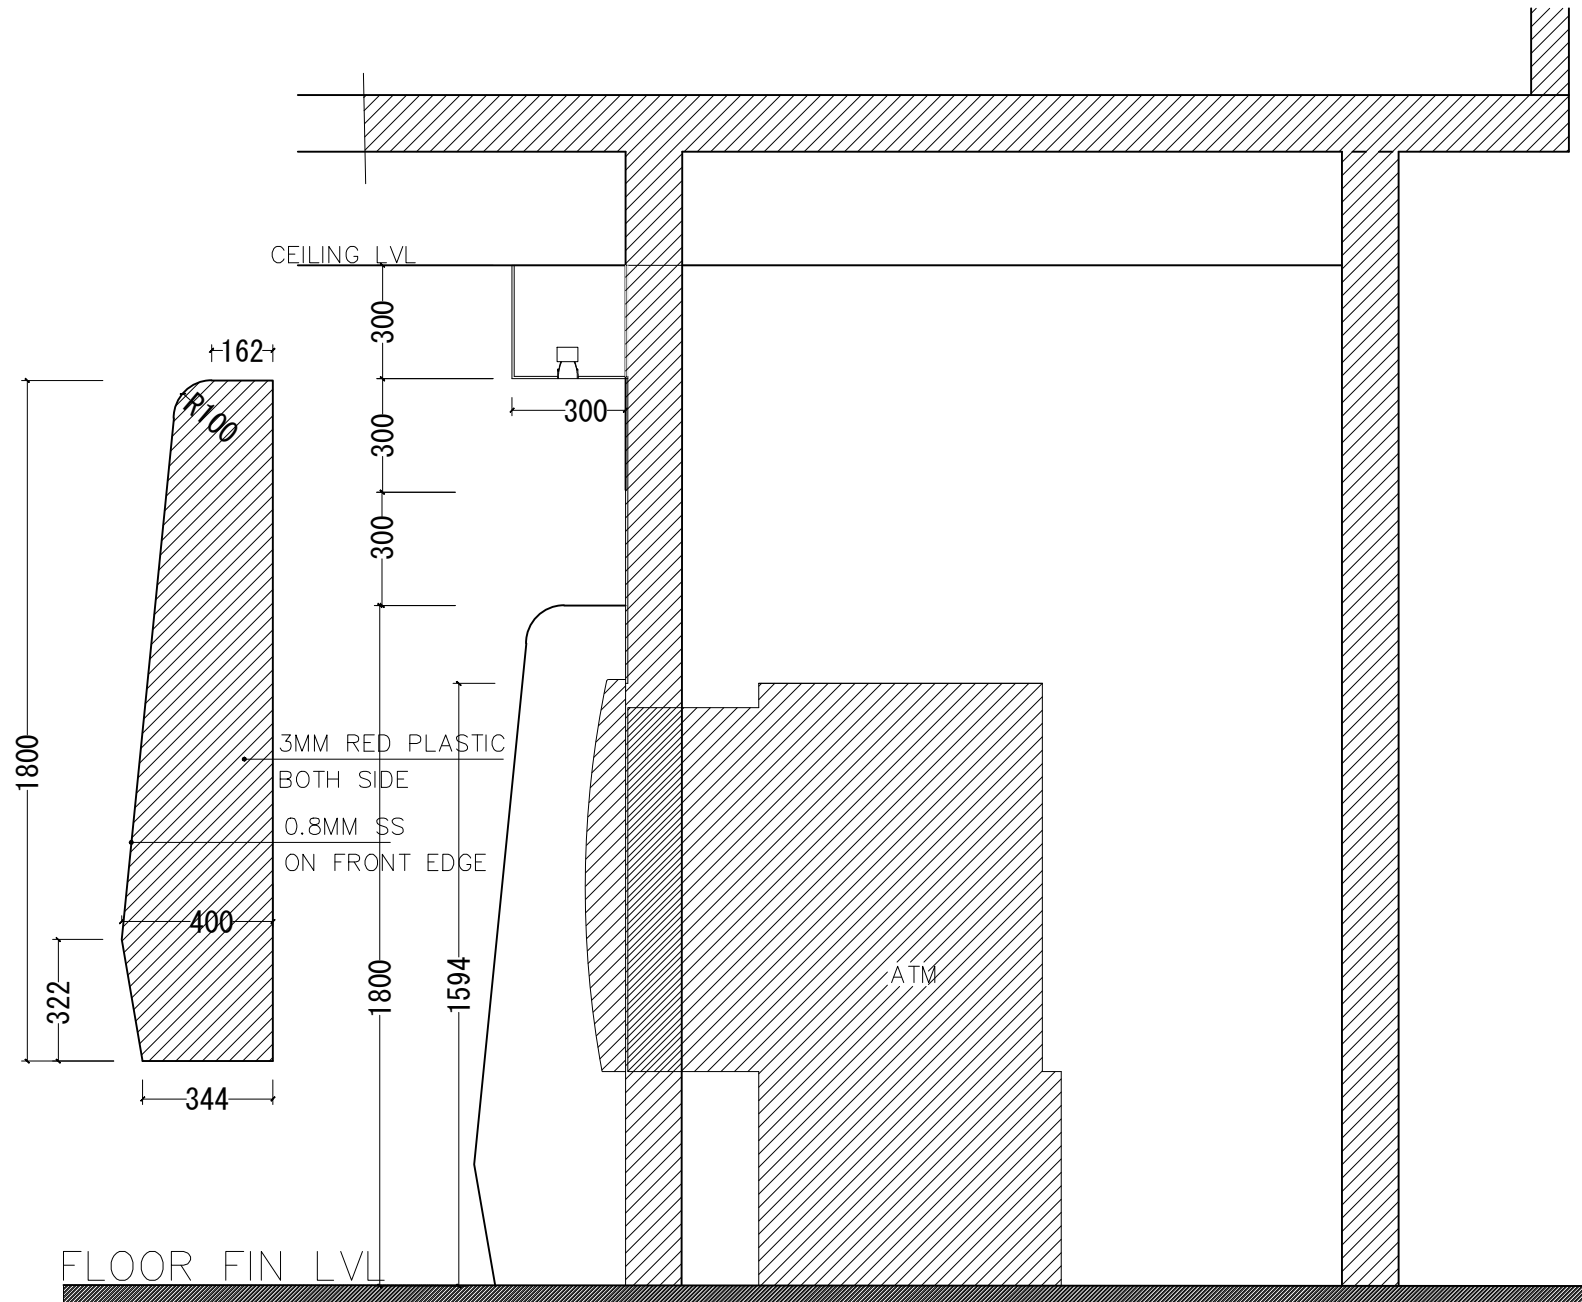

EVEVATION — E2
SCALE 1:20

PROJECT :

BML ATM BOOTH
LAAMU MAAMENDHOO

TITLE :



ATM PARTITION ELEV

CLIENT :

BML PLC

DESIGN BY	MY	
DRAWN BY	MY	
CHECKED		
DATE	MAY 2021	DWG No
SCALE	1:20	A 12/13
PROJECT No		

IF IN DOUBT - ASK - DO NOT SCALE

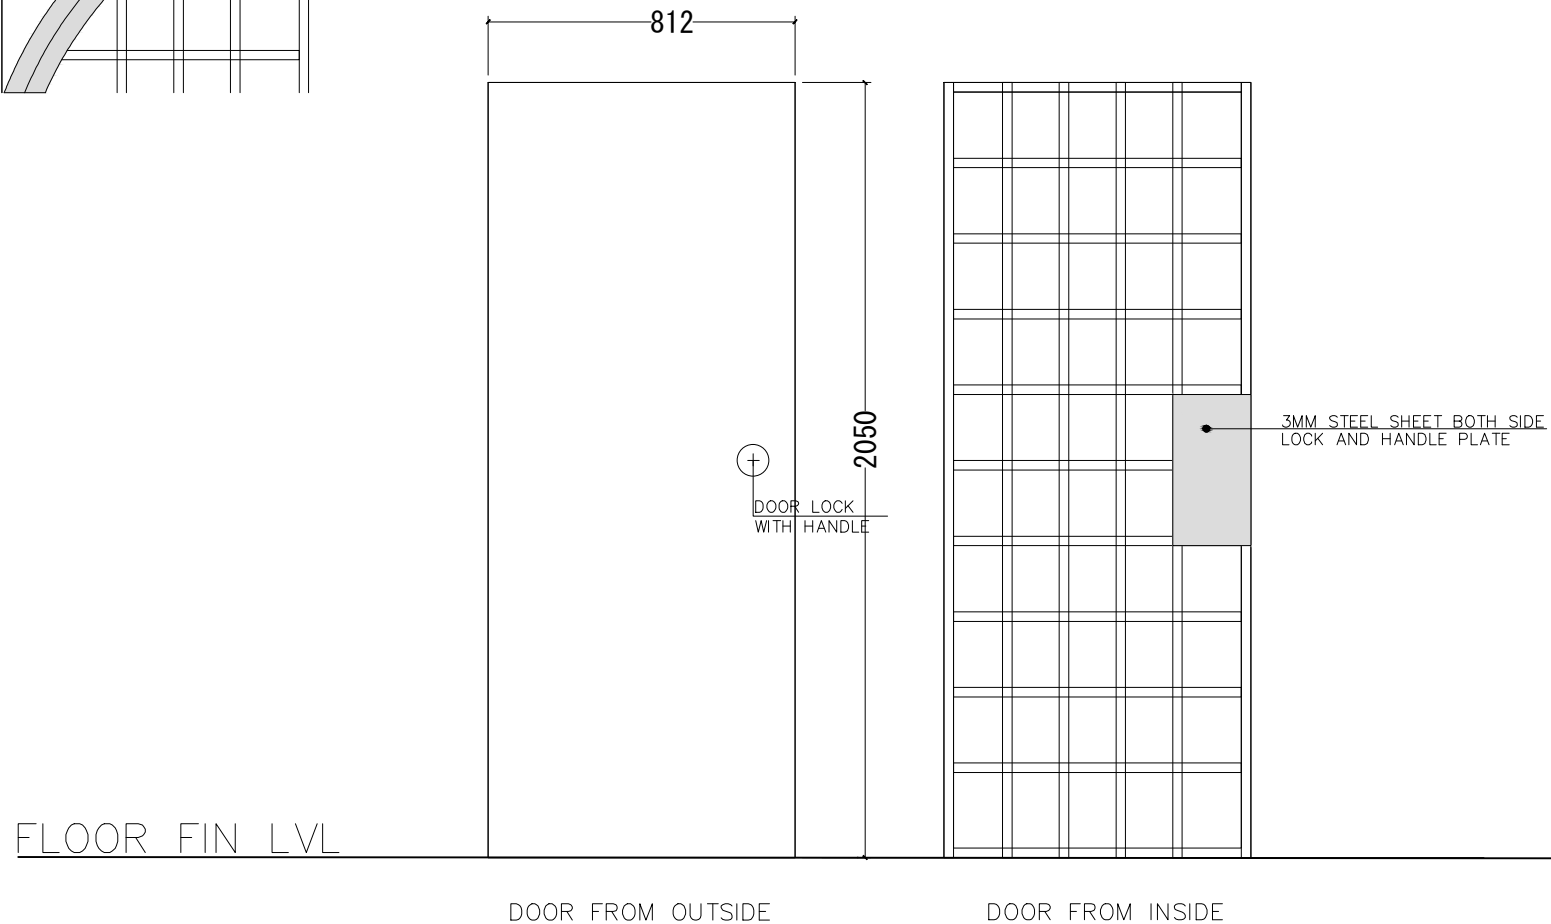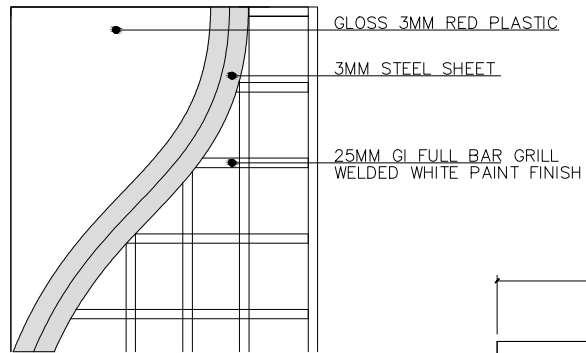

PROJECT :

BML ATM BOOTH
LAAMU MAAMENDHOO

TITLE :

ATM PARTITION ELEV

CLIENT :

BML PLC

DESIGN BY	MY	
DRAWN BY	MY	
CHECKED		
DATE	MAY 2021	DWG No
SCALE	1:20	A 13/13
PROJECT No		

#	မူဝါဒ	အမျိုးအမည်	အမျိုးအမည်	အမျိုးအမည်
1	မြန်မာနိုင်ငံတော် အစိုးရ	1	မြန်မာနိုင်ငံတော် အစိုးရ	မြန်မာနိုင်ငံတော် အစိုးရ
2	မြန်မာနိုင်ငံတော် အစိုးရ	1	မြန်မာနိုင်ငံတော် အစိုးရ	မြန်မာနိုင်ငံတော် အစိုးရ
3	မြန်မာနိုင်ငံတော် အစိုးရ	1	မြန်မာနိုင်ငံတော် အစိုးရ	မြန်မာနိုင်ငံတော် အစိုးရ
4	မြန်မာနိုင်ငံတော် အစိုးရ	24.20	မြန်မာနိုင်ငံတော် အစိုးရ	မြန်မာနိုင်ငံတော် အစိုးရ
5	မြန်မာနိုင်ငံတော် အစိုးရ	8.65	မြန်မာနိုင်ငံတော် အစိုးရ	မြန်မာနိုင်ငံတော် အစိုးရ
6	မြန်မာနိုင်ငံတော် အစိုးရ	24.20	မြန်မာနိုင်ငံတော် အစိုးရ	မြန်မာနိုင်ငံတော် အစိုးရ
7	မြန်မာနိုင်ငံတော် အစိုးရ	1	မြန်မာနိုင်ငံတော် အစိုးရ	မြန်မာနိုင်ငံတော် အစိုးရ
8	မြန်မာနိုင်ငံတော် အစိုးရ	1	မြန်မာနိုင်ငံတော် အစိုးရ	မြန်မာနိုင်ငံတော် အစိုးရ
9	မြန်မာနိုင်ငံတော် အစိုးရ	1	မြန်မာနိုင်ငံတော် အစိုးရ	မြန်မာနိုင်ငံတော် အစိုးရ
10	မြန်မာနိုင်ငံတော် အစိုးရ	1	မြန်မာနိုင်ငံတော် အစိုးရ	မြန်မာနိုင်ငံတော် အစိုးရ

[illegible]

[illegible]

- [illegible]

- [illegible]