




BANK OF MALDIVES SELF SERVICE ATM BOOTH
LH. KURENDHOO
CONSTRUCTION DRAWINGS

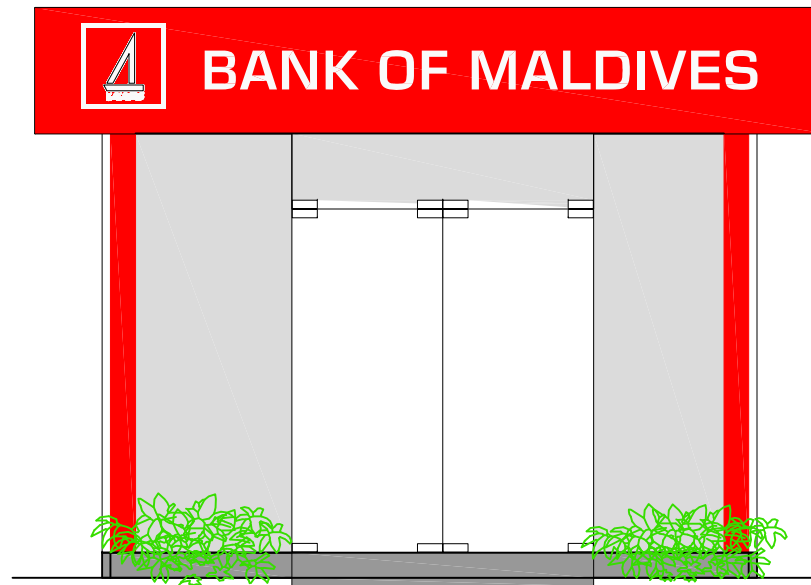

FRONT ELEVATION

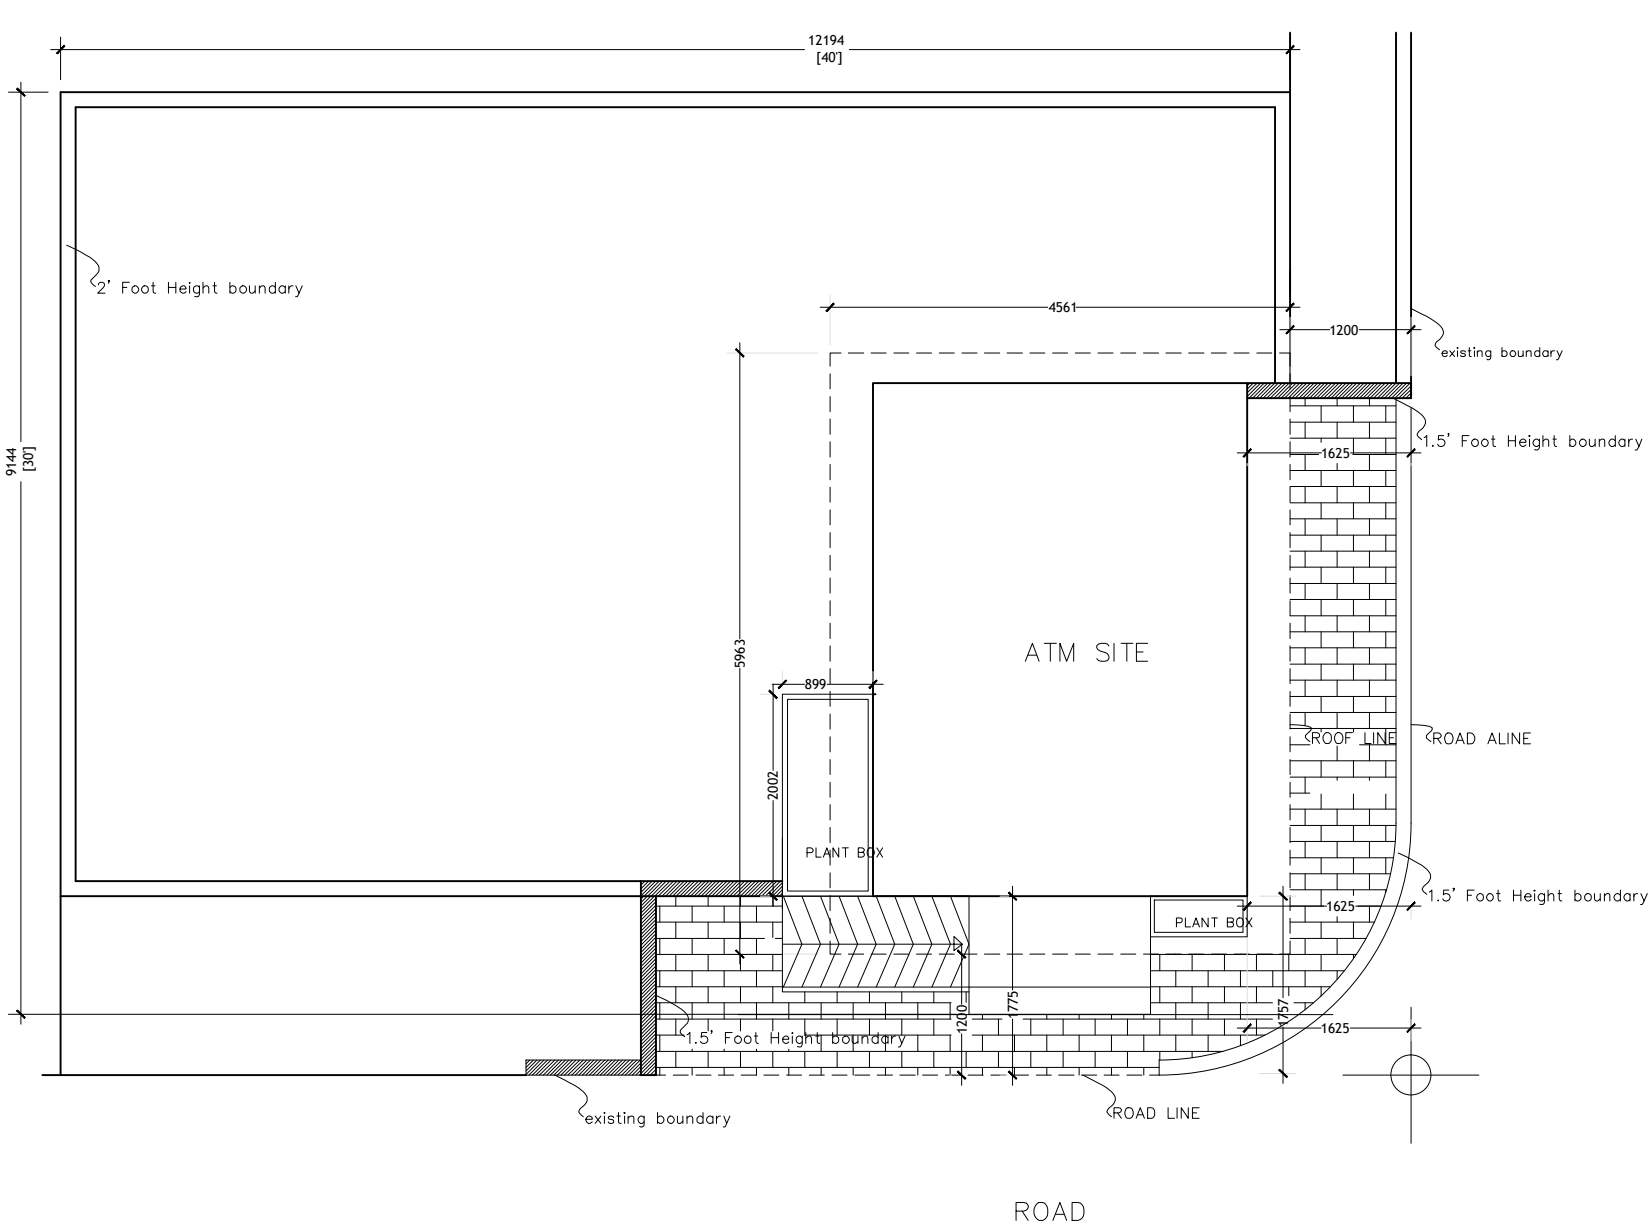

IF IN DOUBT - ASK - DO NOT SCALE

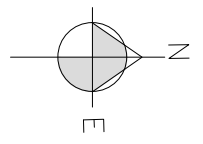

PROJECT :

BML ATM BOOTH
LH. KURENDHOO


TITLE :

SITE PLAN

CLIENT :


BML PLC

DESIGN BY	MY	
DRAWN BY	MY	
CHECKED		
DATE	JUNE 2021	DWG No
SCALE		
PROJECT No		A-01/13

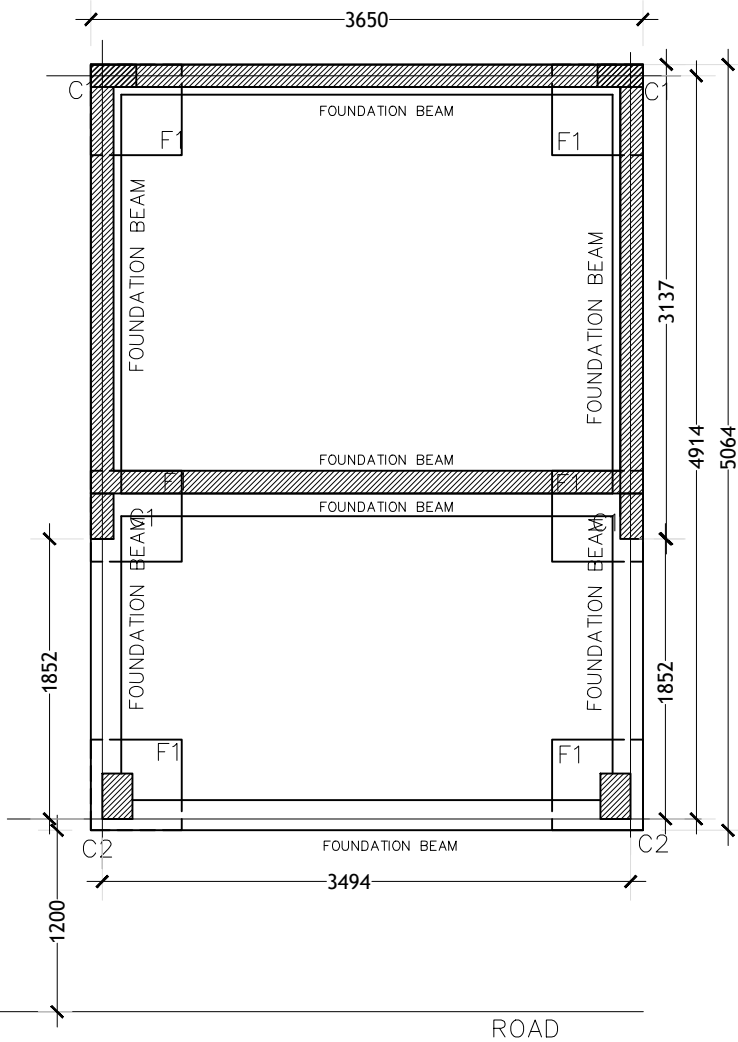

FOUNDATION PLAN
SCALE: 1:50

NOTE:
FOUNDATION DEPTH = 750MM FROM GROUND LVL

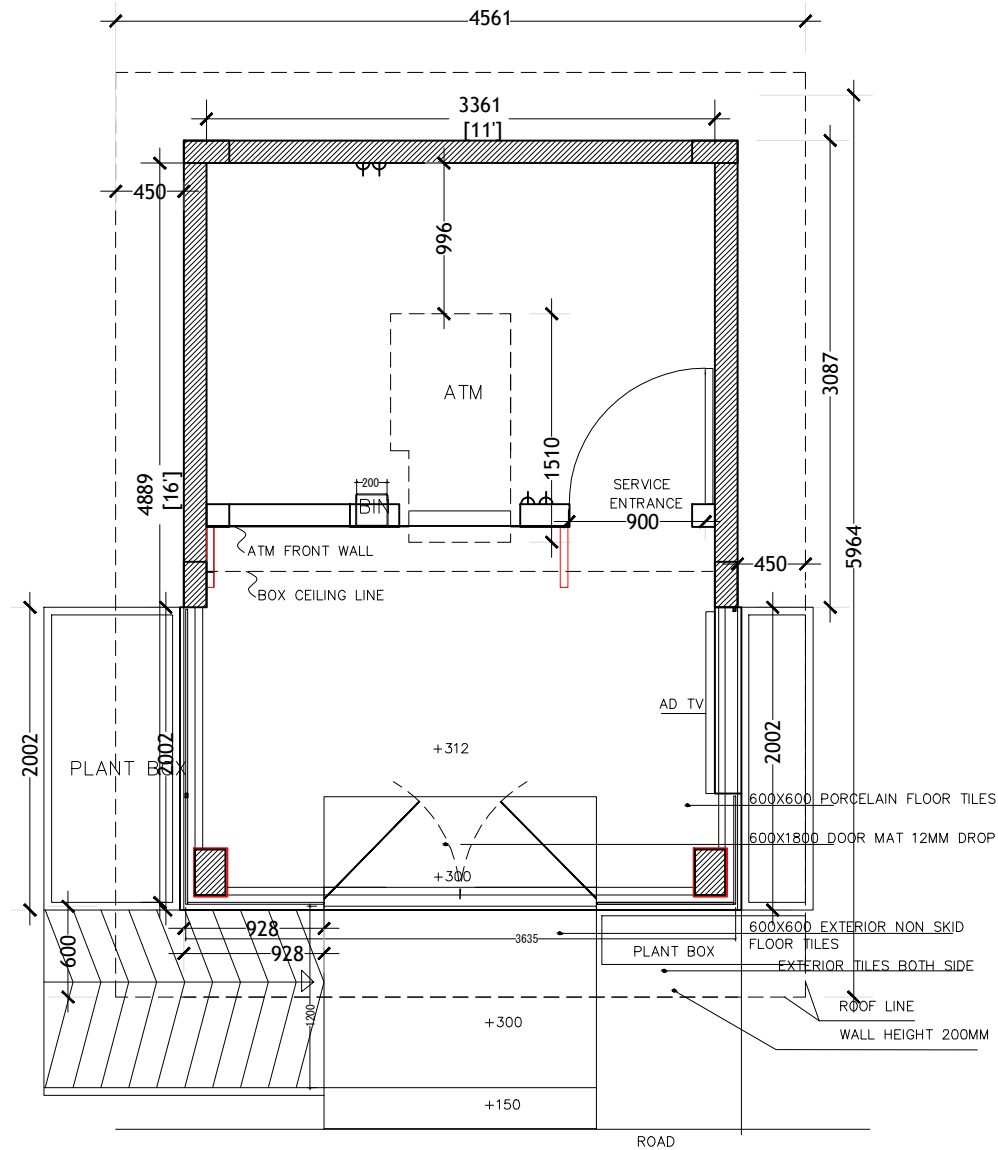

FLOOR PLAN
SCALE: 1:50

± ZERO

IF IN DOUBT - ASK - DO NOT SCALE

PROJECT :

BML ATM BOOTH
LH. KURENDHOO


TITLE :

FLOOR PLAN
FOUNDATION PLAN

CLIENT :


BML PLC

DESIGN BY	MY	
DRAWN BY	MY	
CHECKED		
DATE	JUNE 2021	DWG No
SCALE	1:50	A-02/13
PROJECT No		

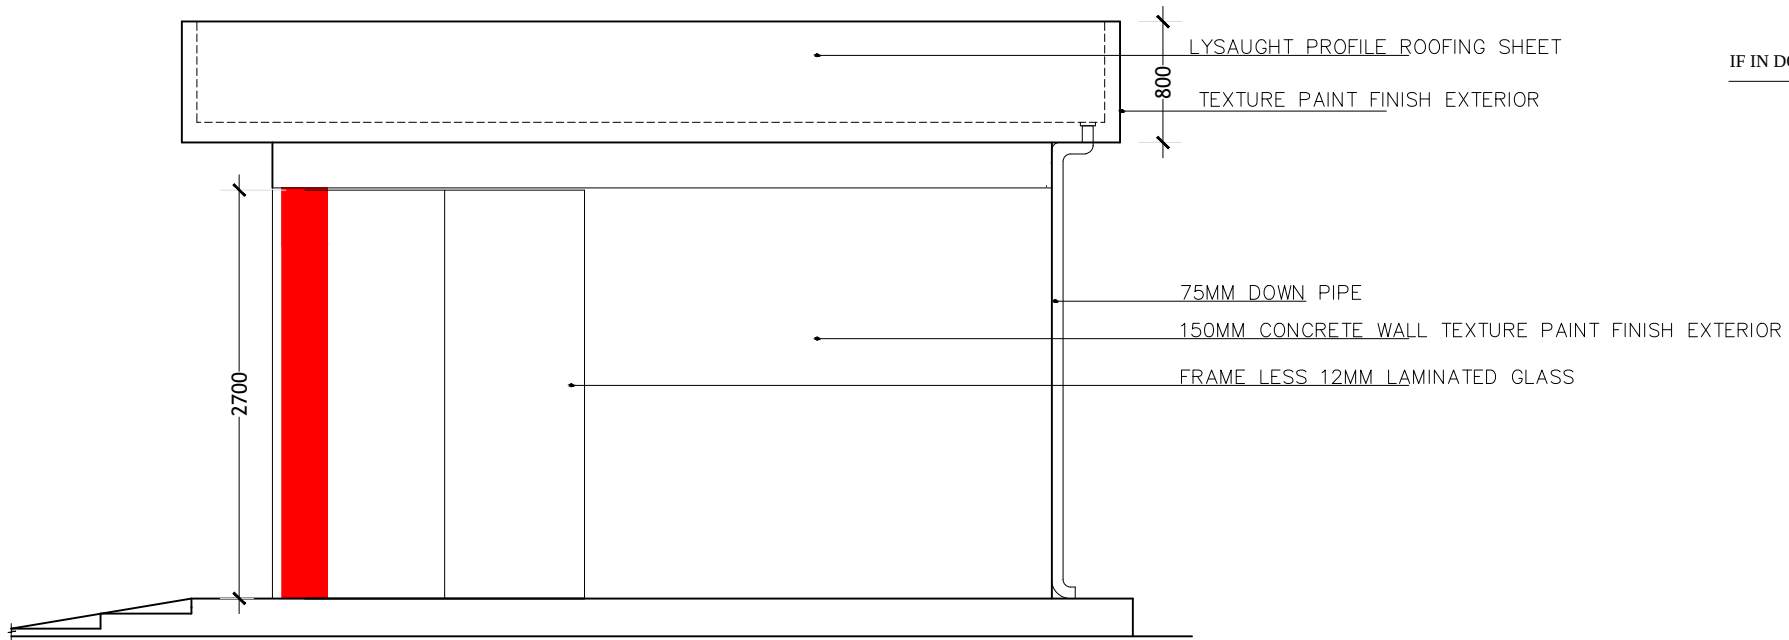

SIDE ELEVATION
SCALE: 1:50

IF IN DOUBT - ASK - DO NOT SCALE

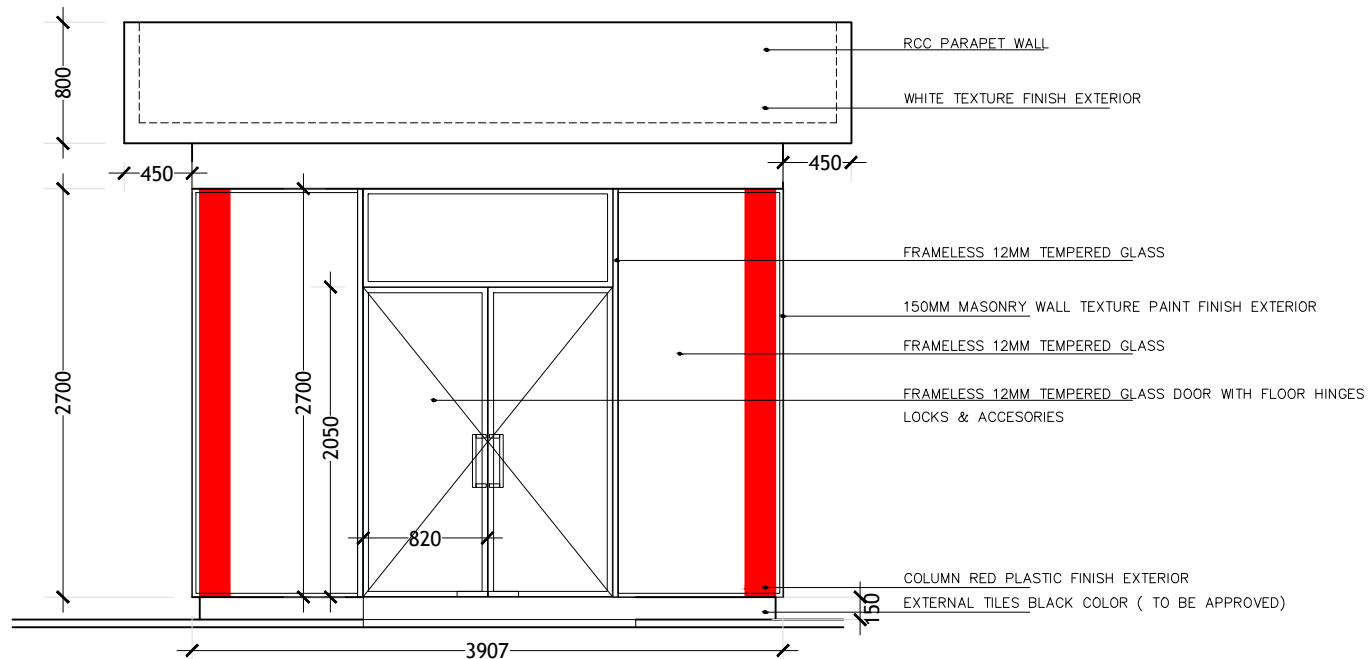

FRONT ELEVATION
SCALE: 1:50

PROJECT :

BML ATM BOOTH
LH. KURENDHOO

TITLE :


FRNT ELEVATION
SIDE ELEVATION

CLIENT :

BML PLC

DESIGN BY	MY		
DRAWN BY	MY		
CHECKED			
DATE	JUNE 2021	DWG No	
SCALE	1:50	A-03/13	
PROJECT No			

IF IN DOUBT - ASK - DO NOT SCALE

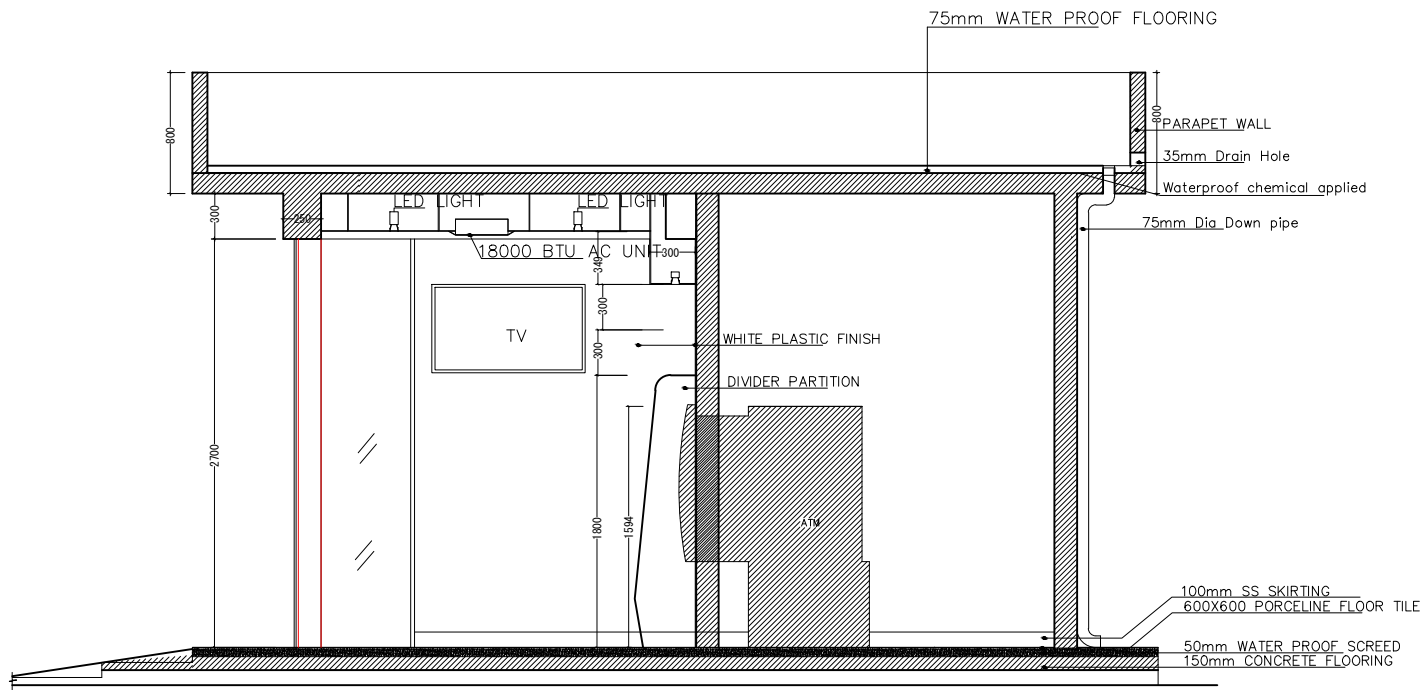

SECTION -A
SCALE: 1:50

PROJECT :

BML ATM BOOTH
LH. KURENDHOO


TITLE :

SECTION A

CLIENT :

BML PLC


DESIGN BY	MY	
DRAWN BY	MY	
CHECKED		
DATE	JUNE 2021	DWG No
SCALE	1:50	A- 04/13
PROJECT No		

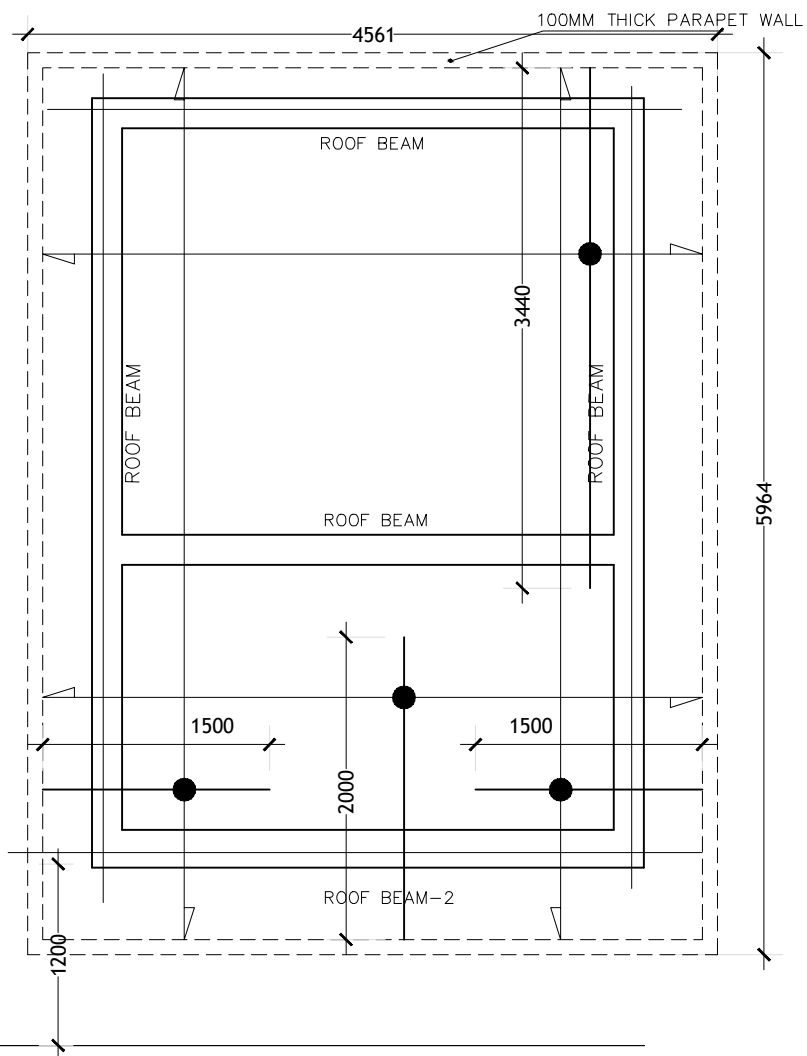

ROOF REINFORCEMENT PLAN
SCALE: 1:50

NOTE

TOP REINFORCEMENT : T10@150 C/C BW (SHOWN)
BOTTOM REINFORCEMENT : T10@150 C/C BW (NOT SHOWN)

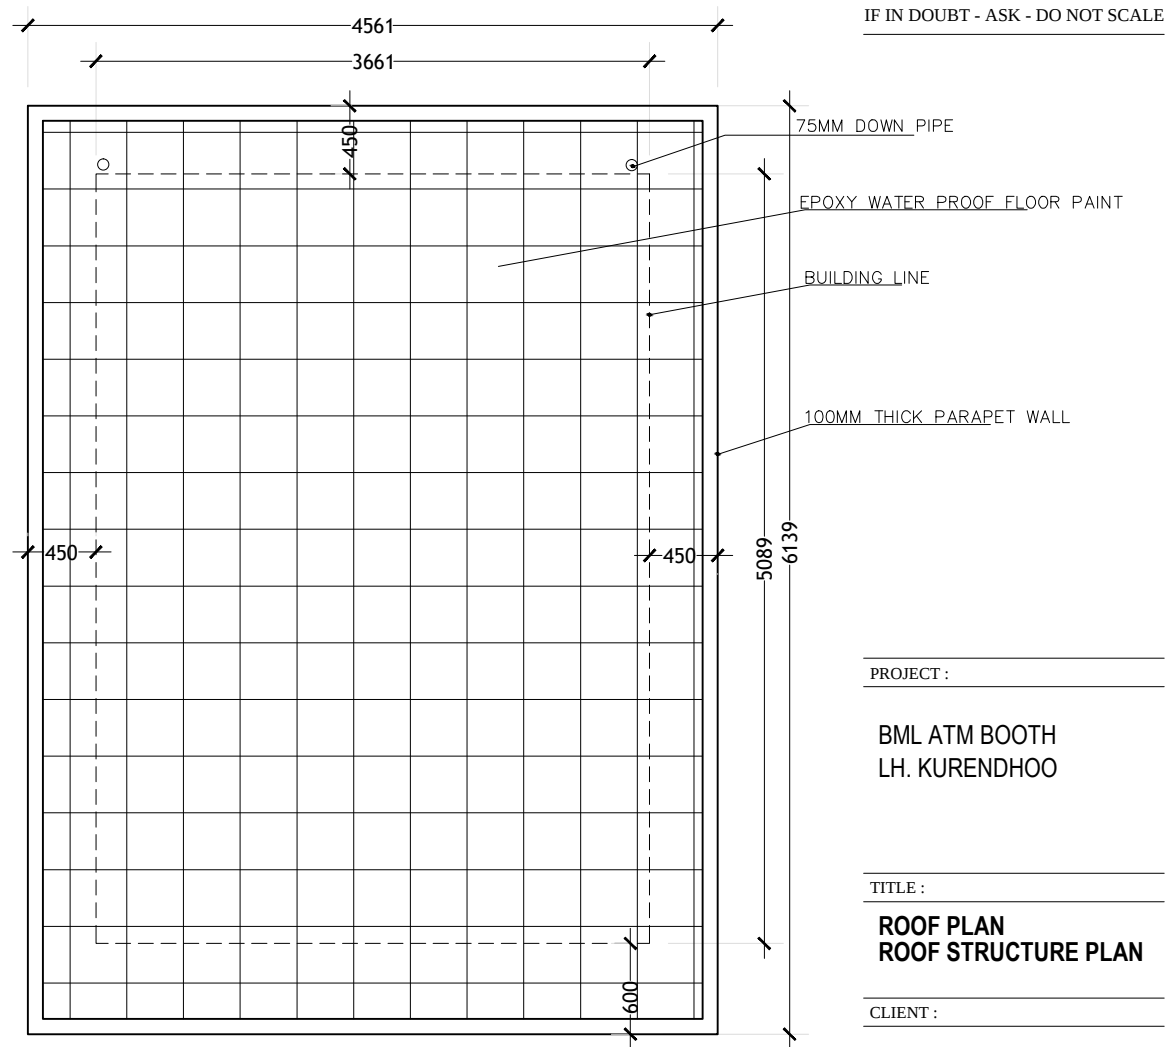

ROOF PLAN
SCALE: 1:50

PROJECT :

BML ATM BOOTH
LH. KURENDHOO

TITLE :


ROOF PLAN
ROOF STRUCTURE PLAN

CLIENT :

BML PLC


DESIGN BY	MY	
DRAWN BY	MY	
CHECKED		
DATE	JUNE 2021	DWG No
SCALE	1:50	A-05/13
PROJECT No		

IF IN DOUBT - ASK - DO NOT SCALE

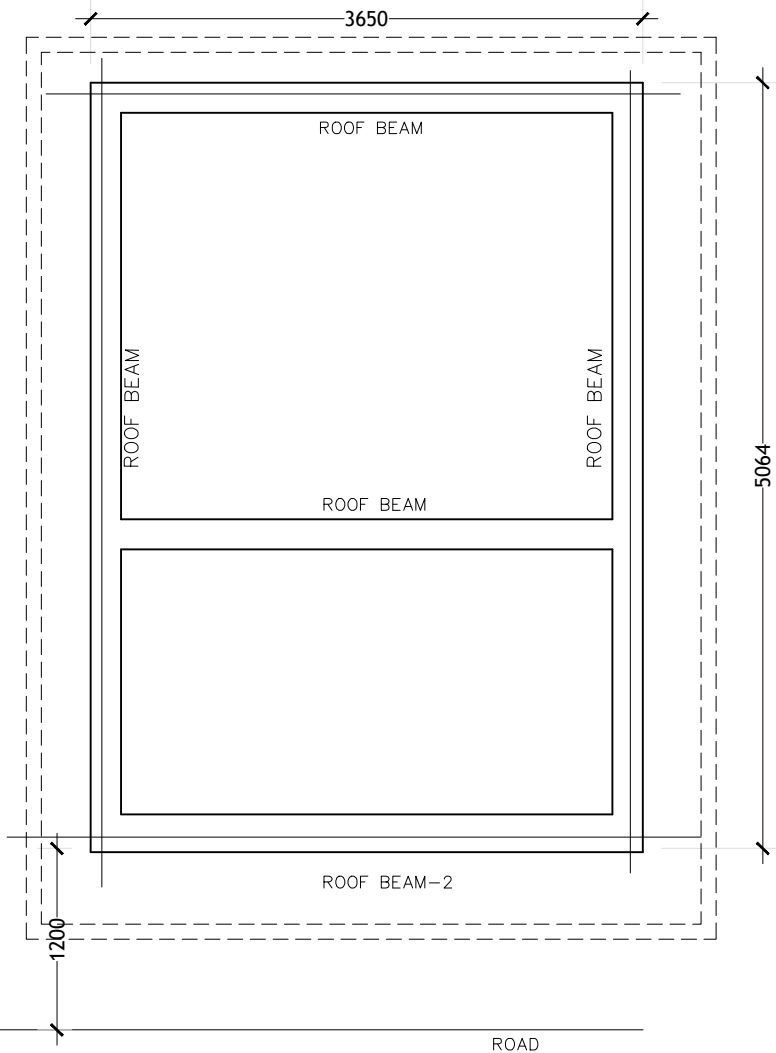

ROOF BEAM PLAN
SCALE: 1:50

NOTE:
GUTTER SLAB THICKNESS = 135MM

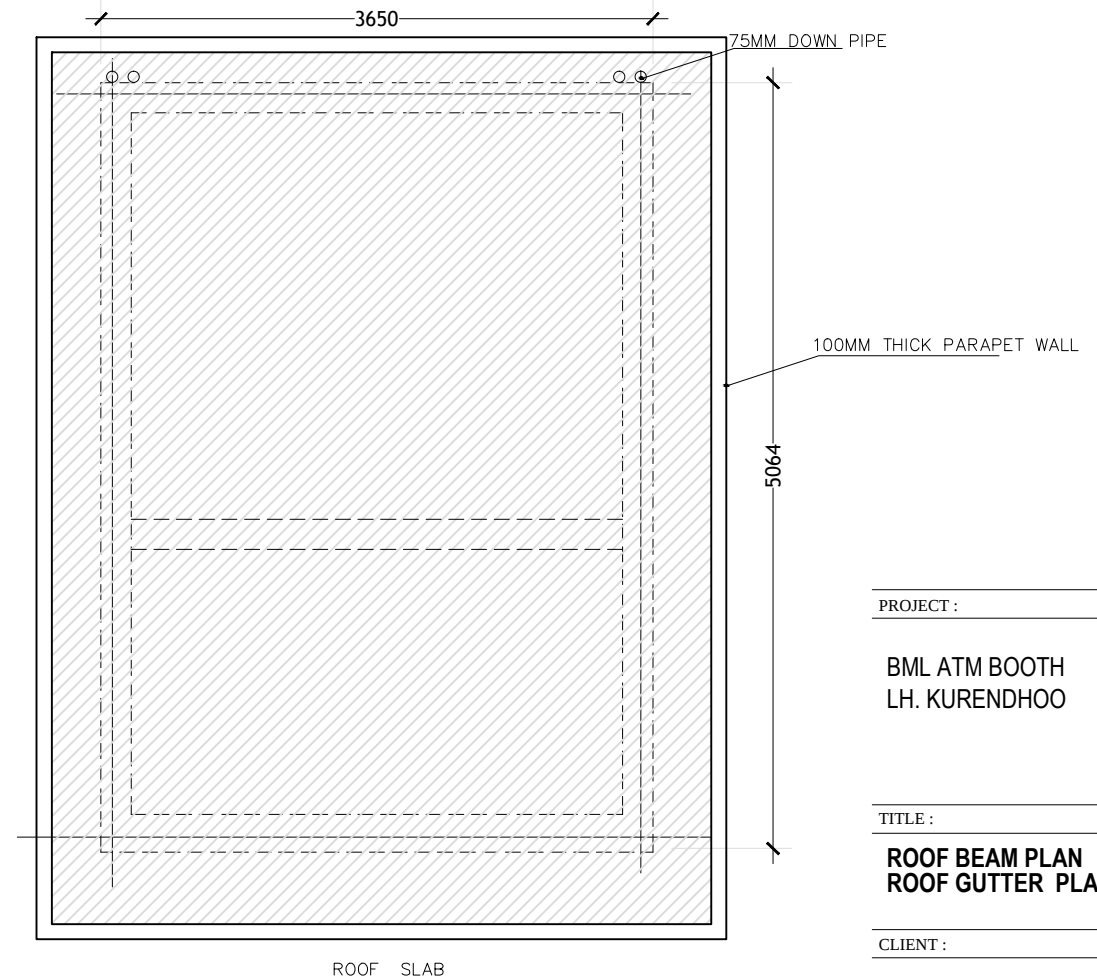

ROOF SLAB PLAN
SCALE: 1:50

PROJECT :

BML ATM BOOTH
LH. KURENDHOO


TITLE :

**ROOF BEAM PLAN
ROOF GUTTER PLAN**

CLIENT :


BML PLC

DESIGN BY	MY	
DRAWN BY	MY	
CHECKED		
DATE	JUNE 2021	DWG No
SCALE	1:50	A-06/13
PROJECT No		

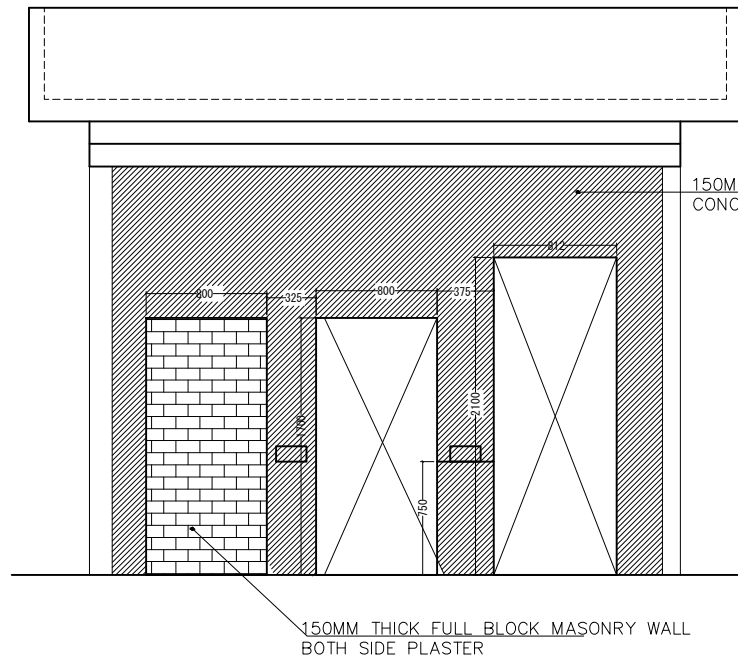

ATM ROOM FRONT WALL
SCALE: 1:50

NOTE:
3 SIDE CONCRETE WALL
FRONT WALL AS PER THE ELEVATION SHOWN
TOP 150MM THICK CONCRETE 27.75 SQM
FLOOR 150MM THICK CONCRETE 18.75SQM

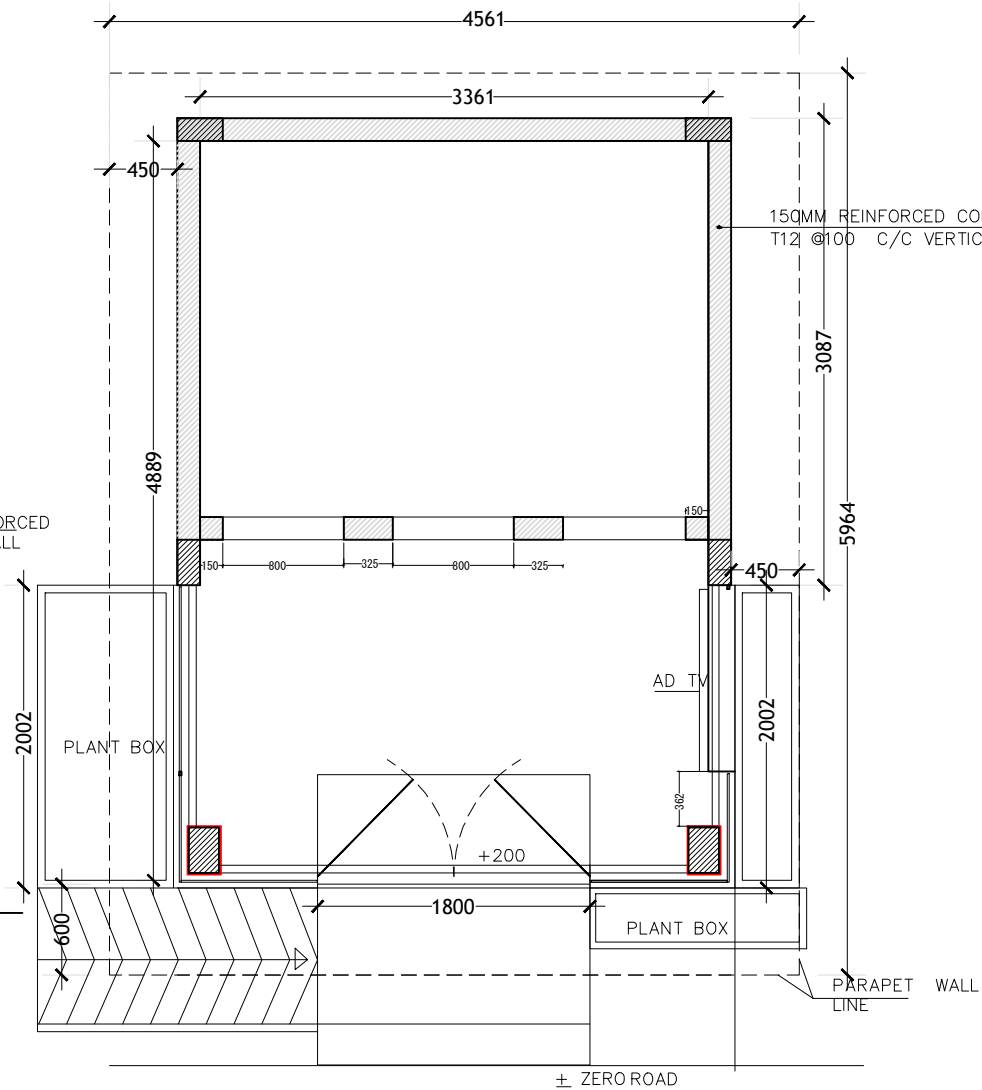

FLOOR PLAN
SCALE: 1:50

IF IN DOUBT - ASK - DO NOT SCALE

PROJECT :

BML ATM BOOTH
LH. KURENDHOO


TITLE :


CONCRETE WALLS

CLIENT :

BML PLC

DESIGN BY	MY	
DRAWN BY	MY	
CHECKED		
DATE	JUNE 2021	DWG No
SCALE	1:50	A-07/13
PROJECT No		

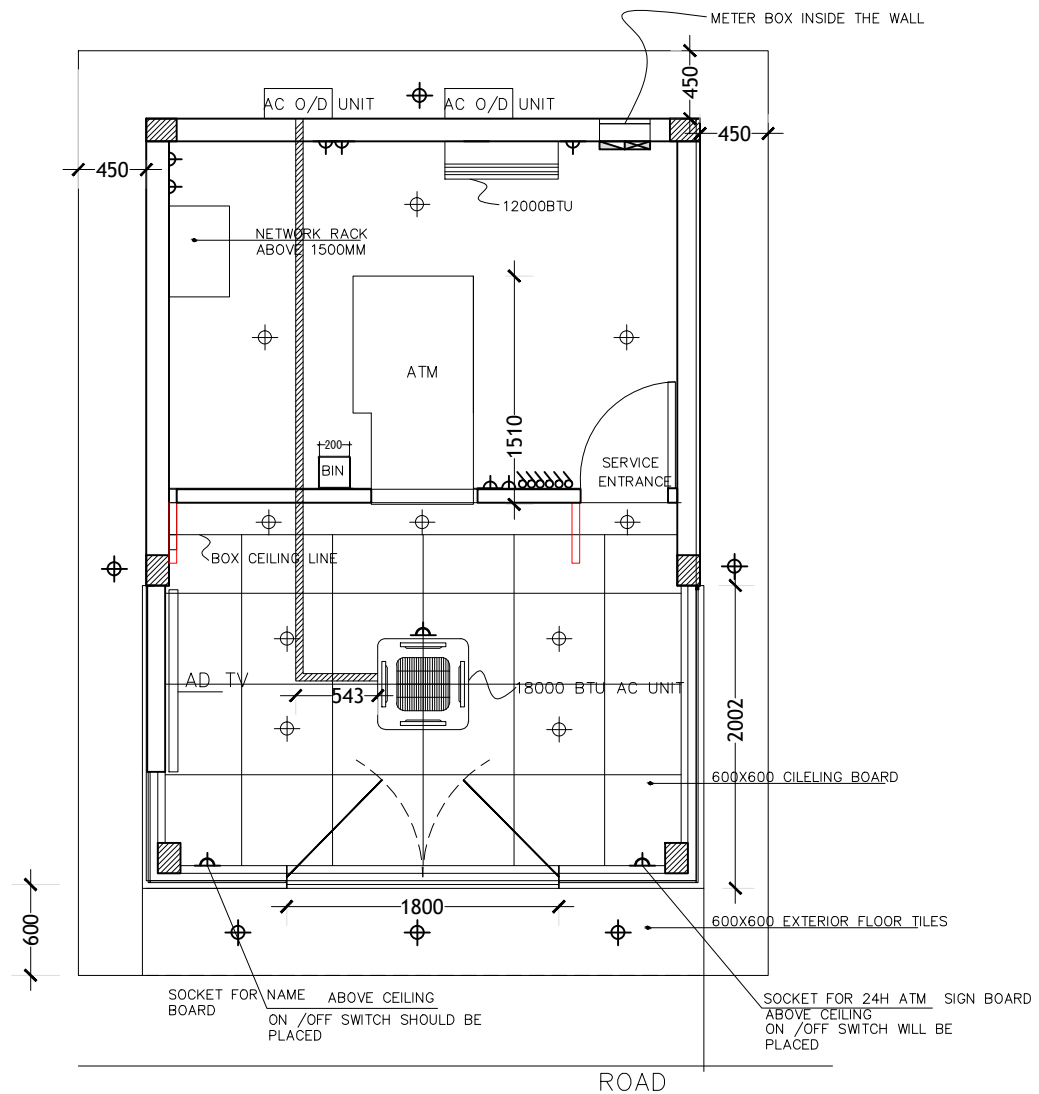

 -  SPLIT TYPE INVERTER AIR CONDITION
-  CEILING CASSETTE INVERTER AIR CONDITION
-  3PH HOUSE METER & EXTERNAL DB
-  DISTRIBUTION BOX
-  1GANG 16AMP SOCKETS FOR AC
-  SWITCHES
-  2GANG 13AMP SOCKETS
-  CEILING RECESS OUTDOOR LED LIGHT 15WATT
-  CEILING RECESS LED LIGHT 15WATT

PROJECT :

BML ATM BOOTH
LH. KURENDHOO

TITLE :

ELECTRICAL PLAN


CLIENT :

BML PLC

DESIGN BY	MY	
DRAWN BY	MY	
CHECKED		
DATE	JUNE 2021	DWG No
SCALE	1:50	A-08/13
PROJECT No		

FLOOR PLAN
SCALE: 1:50

IF IN DOUBT - ASK - DO NOT SCALE

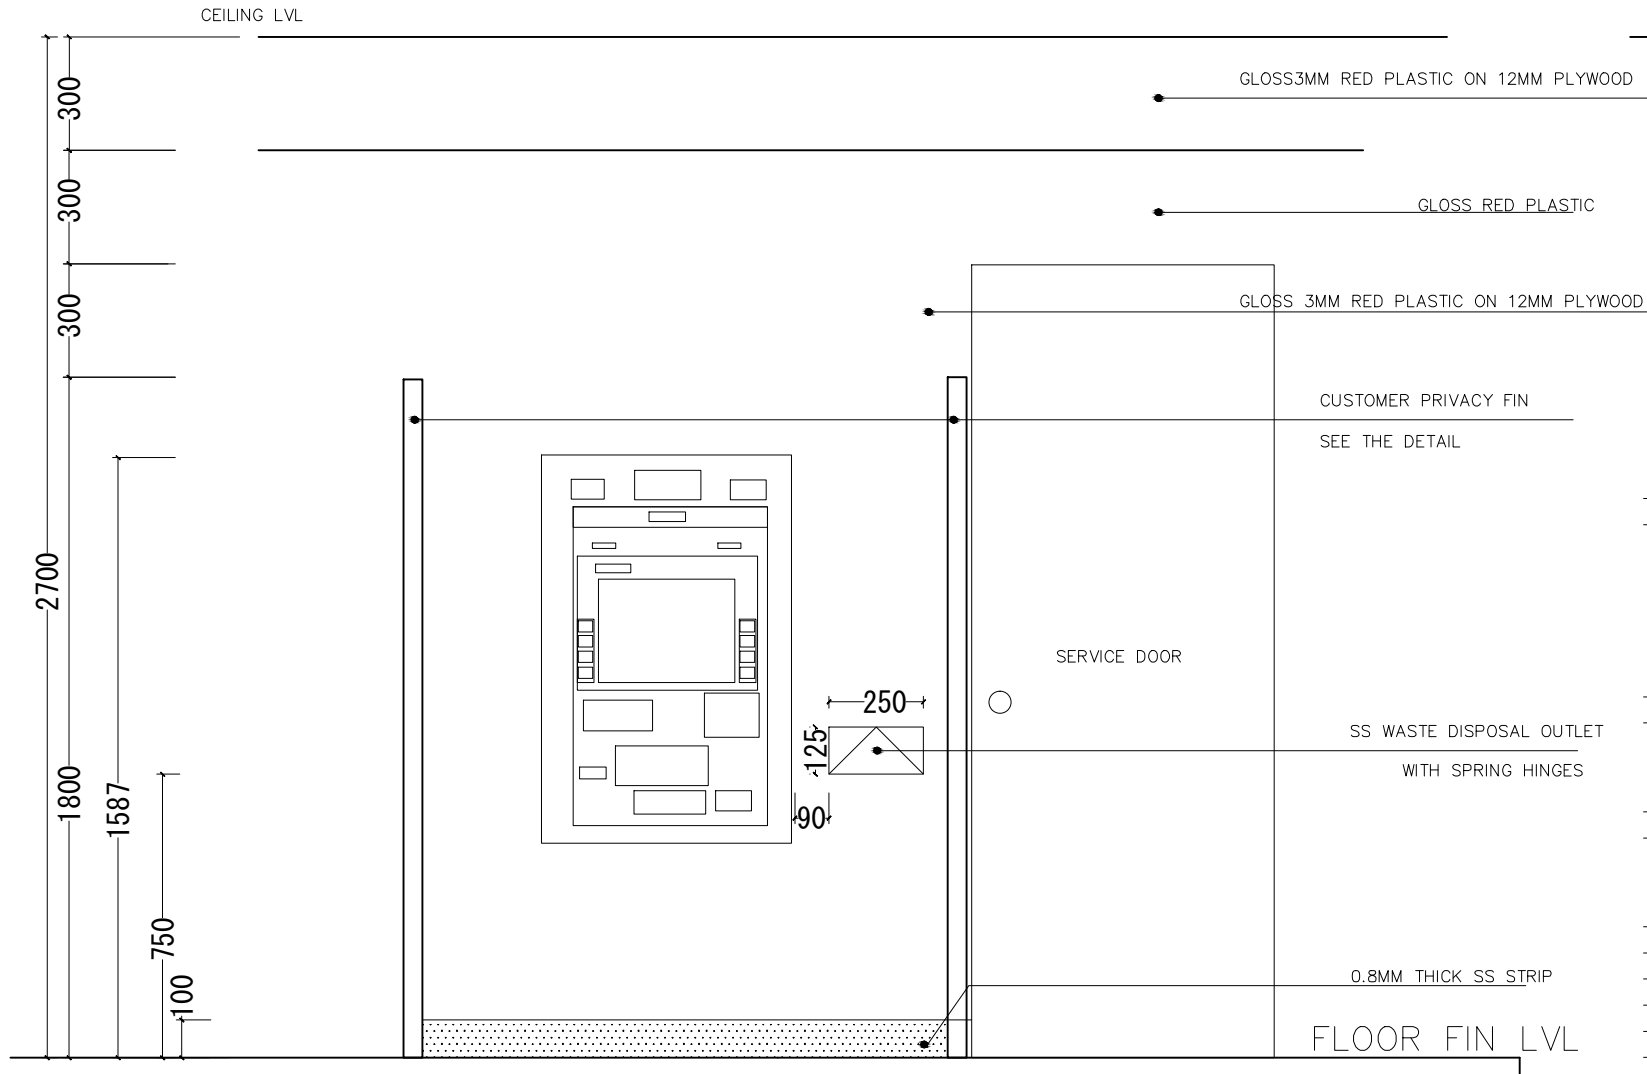

PROJECT :

BML ATM BOOTH
LH. KURENDHOO

TITLE :

ATM PARTITION ELEV


CLIENT :

BML PLC

DESIGN BY	MY	
DRAWN BY	MY	
CHECKED		
DATE	JUNE 2021	DWG No
SCALE	1:20	A 09/13
PROJECT No		

ELEVATION - E1
SCALE 1:20

IF IN DOUBT - ASK - DO NOT SCALE

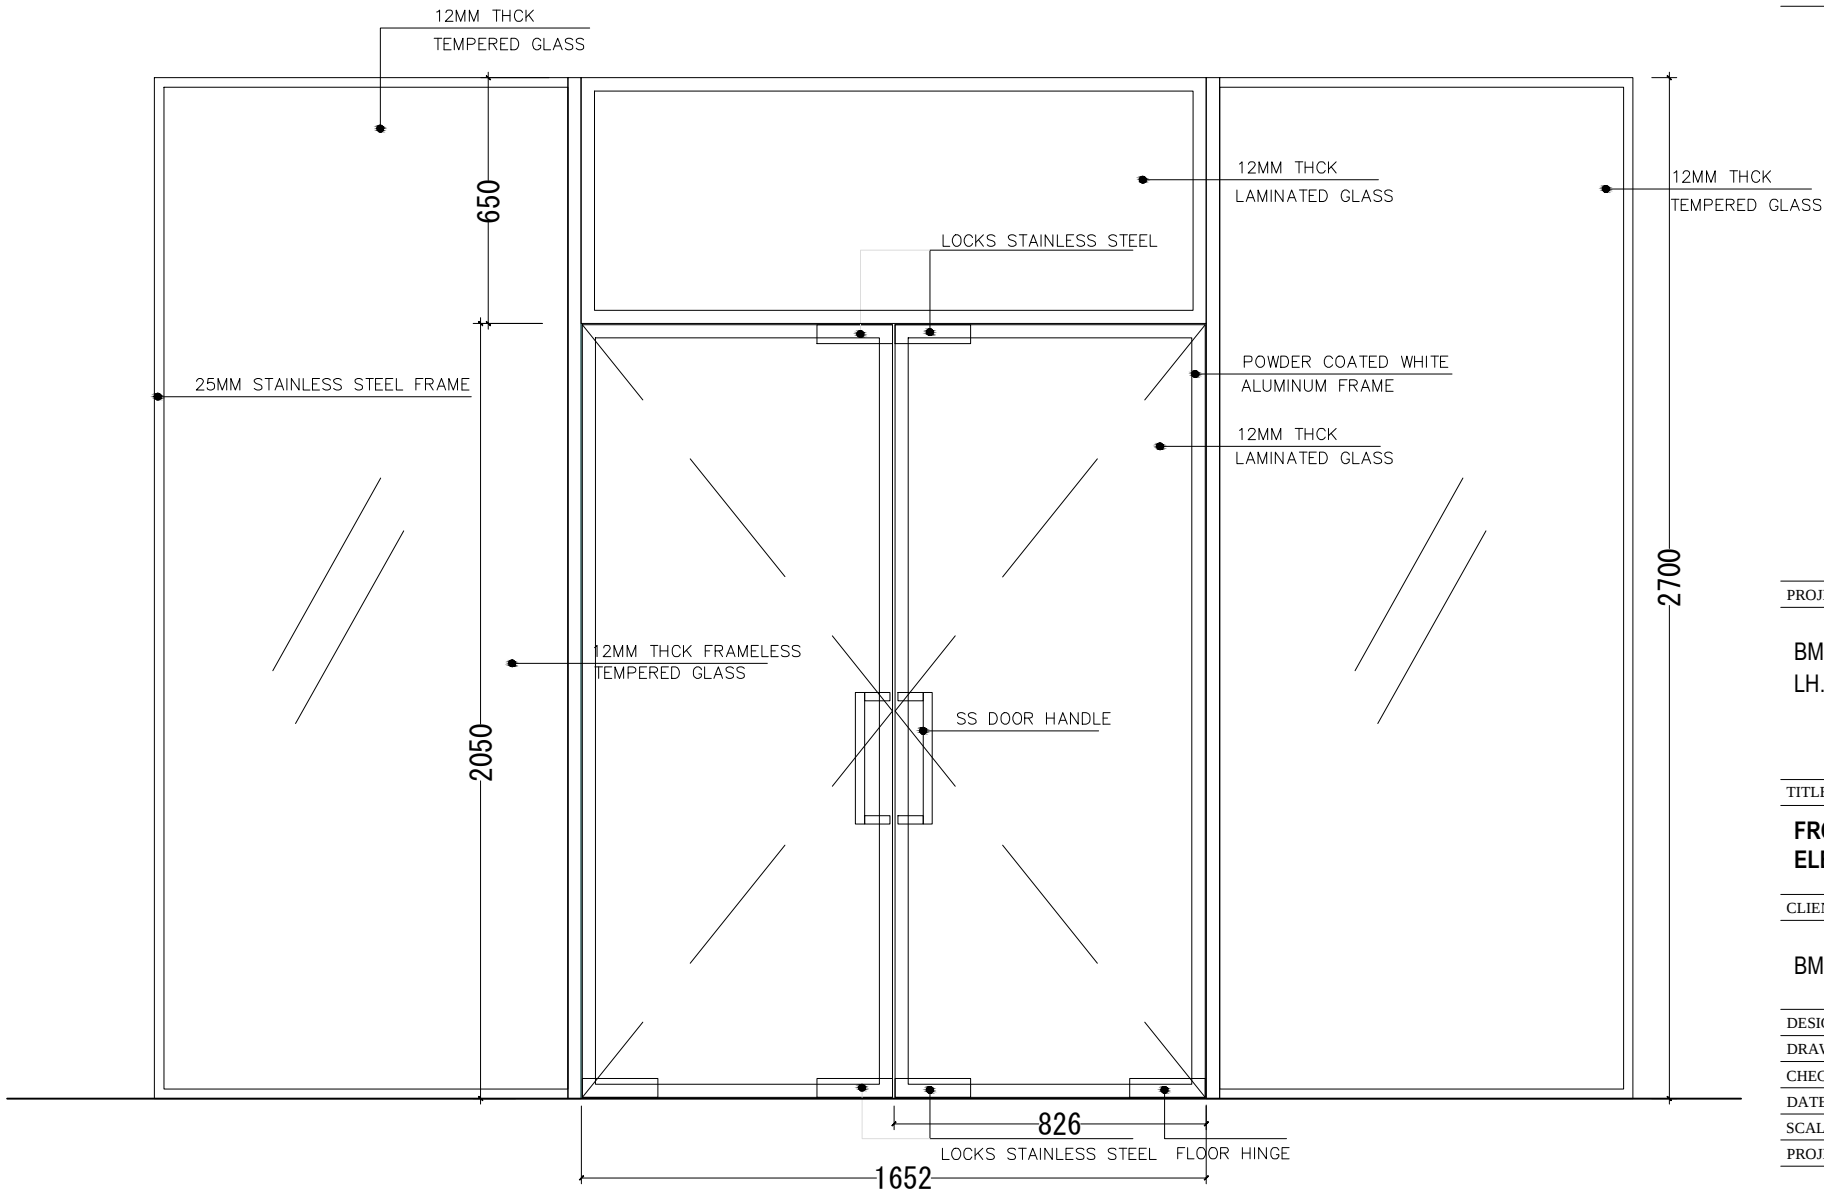

PROJECT :

BML ATM BOOTH
LH. KURENDHOO

TITLE :



FRONT GLASS & DOOR
ELEV

CLIENT :


BML PLC

DESIGN BY	MY	
DRAWN BY	MY	
CHECKED		
DATE	JUNE 2021	DWG No
SCALE	1:20	A 10/13
PROJECT No		


IF IN DOUBT - ASK - DO NOT SCALE

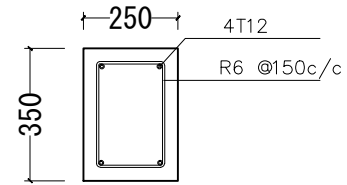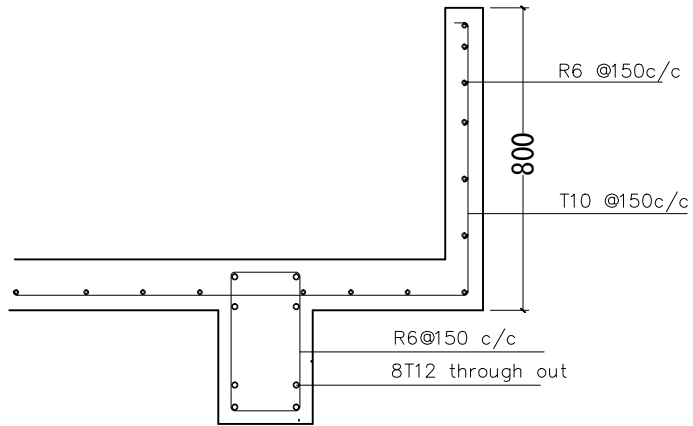


FOUNDATION BEAM

 


COLUMN
(C -1)

 

COLUMN
(C -2)

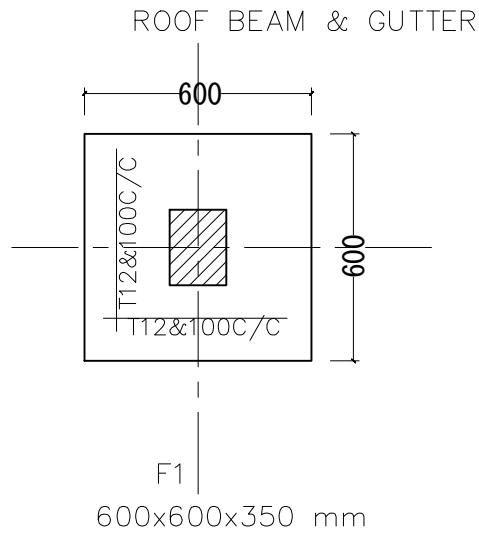

STRUCTURAL DETAIL

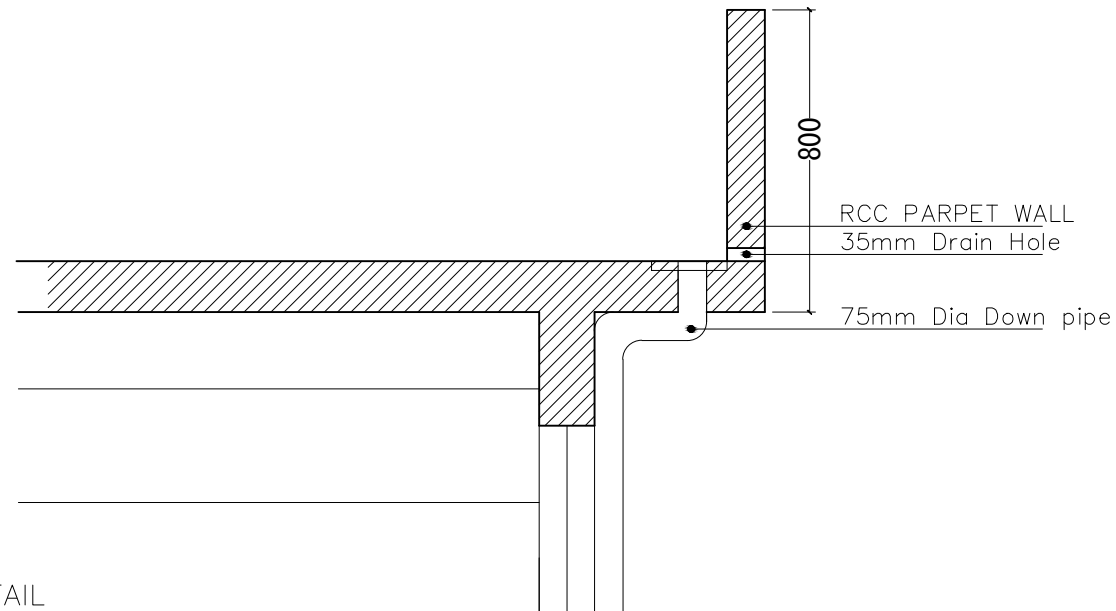

PROJECT :

BML ATM BOOTH
LH. KURENDHOO


TITLE :

STRUCTURAL DETAILS

CLIENT :

BML PLC

DESIGN BY	MY	
DRAWN BY	MY	
CHECKED		
DATE	JUNE 2021	DWG No
SCALE	1:20	A 11/13
PROJECT No		

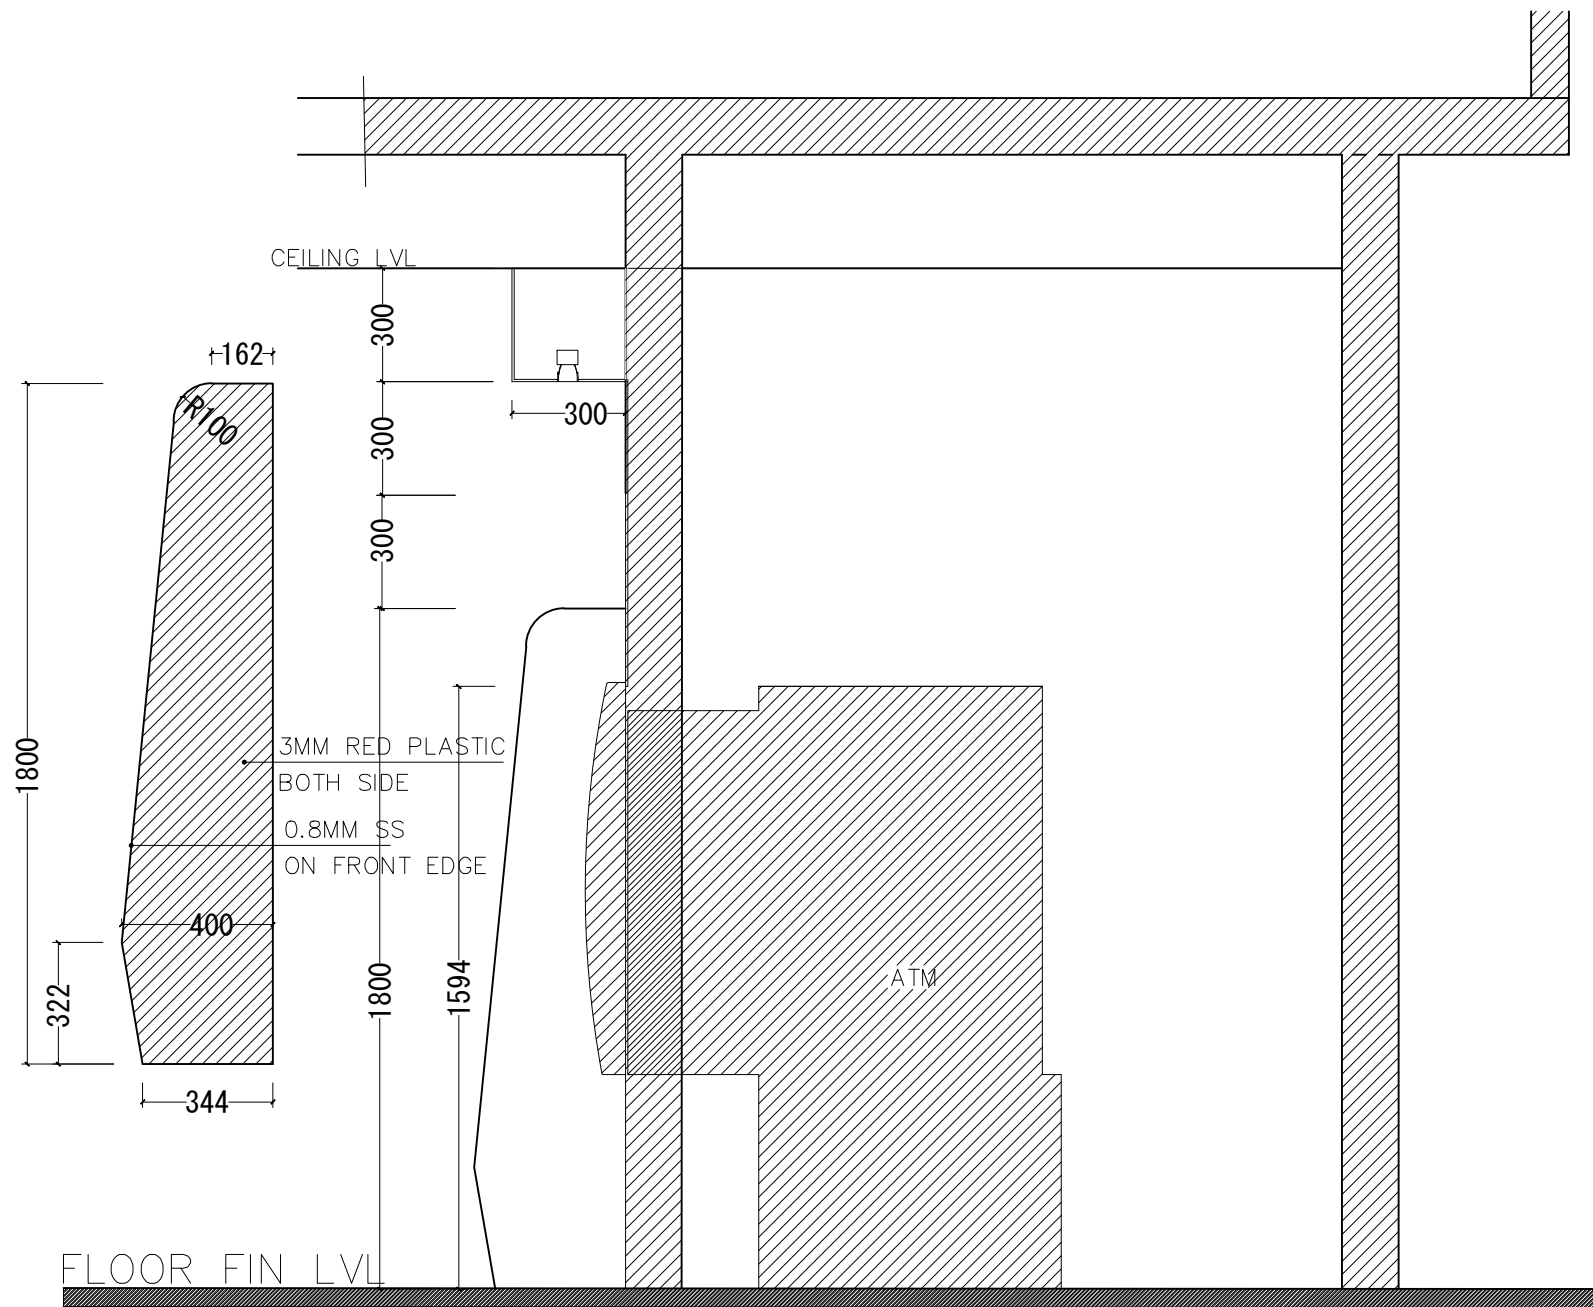

IF IN DOUBT - ASK - DO NOT SCALE

PROJECT :

BML ATM BOOTH
LH. KURENDHOO

TITLE :

ATM PARTITION ELEV



CLIENT :

BML PLC

DESIGN BY	MY	
DRAWN BY	MY	
CHECKED		
DATE	JUNE 2021	DWG No
SCALE	1:20	A 12/13
PROJECT No		

EVEVATION - E2
SCALE 1:20

IF IN DOUBT - ASK - DO NOT SCALE

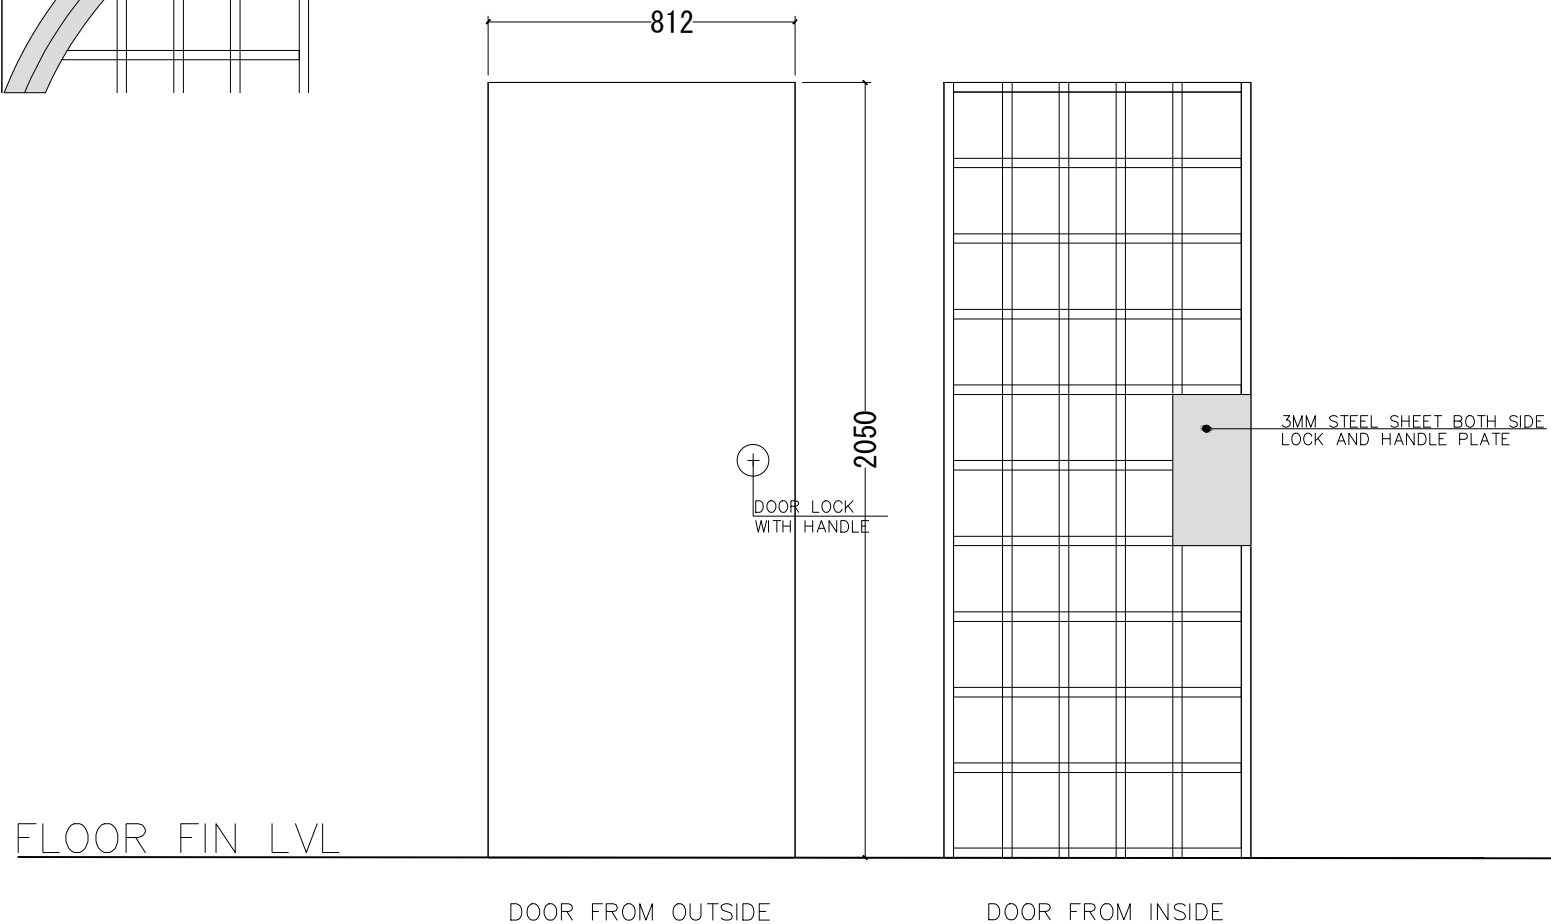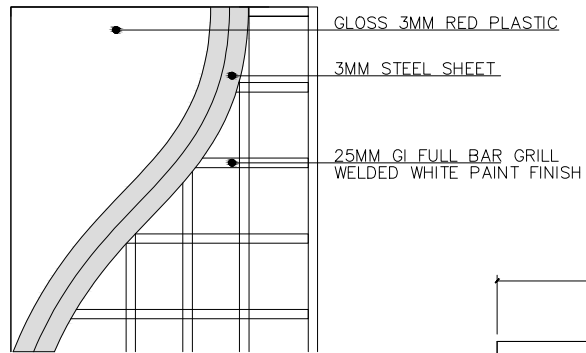

PROJECT :

BML ATM BOOTH
LH. KURENDHOO

TITLE :

ATM PARTITION ELEV

CLIENT :

BML PLC

DESIGN BY	MY	
DRAWN BY	MY	
CHECKED		
DATE	JUNE 2021	DWG No
SCALE	1:20	A 13/13
PROJECT No		

#	مۆھىمىيەت	نەتىجىسى	دەرىجىسى	مەبلەغى	مەبلەغىنىڭ نەتىجىسى
1	1	1	1	1	1
2	2	2	2	2	2
3	3	3	3	3	3
4	4	4	4	4	4
5	5	5	5	5	5
6	6	6	6	6	6
7	7	7	7	7	7
8	8	8	8	8	8
9	9	9	9	9	9

	نِسْبَةُ ٦%
	نِسْبَةُ ٦% نِسْبَةُ ٦% نِسْبَةُ ٦%

BML / PROPERTIES DEVELOPMENT

[illegible]

- دَسُوں دَاغُوں جِي غُٹُوں دِی جُڑُوں دَاغُوں دَاغُوں دَاغُوں

- [illegible]