


H.REAL GROUND FLOOR PARTITION LAYOUT

SCALE: 1 : 100

100MM THK. TIMBER FRAMED FULL HEIGHT
GYPSUM PARTITION 2400-3000mm HIGH

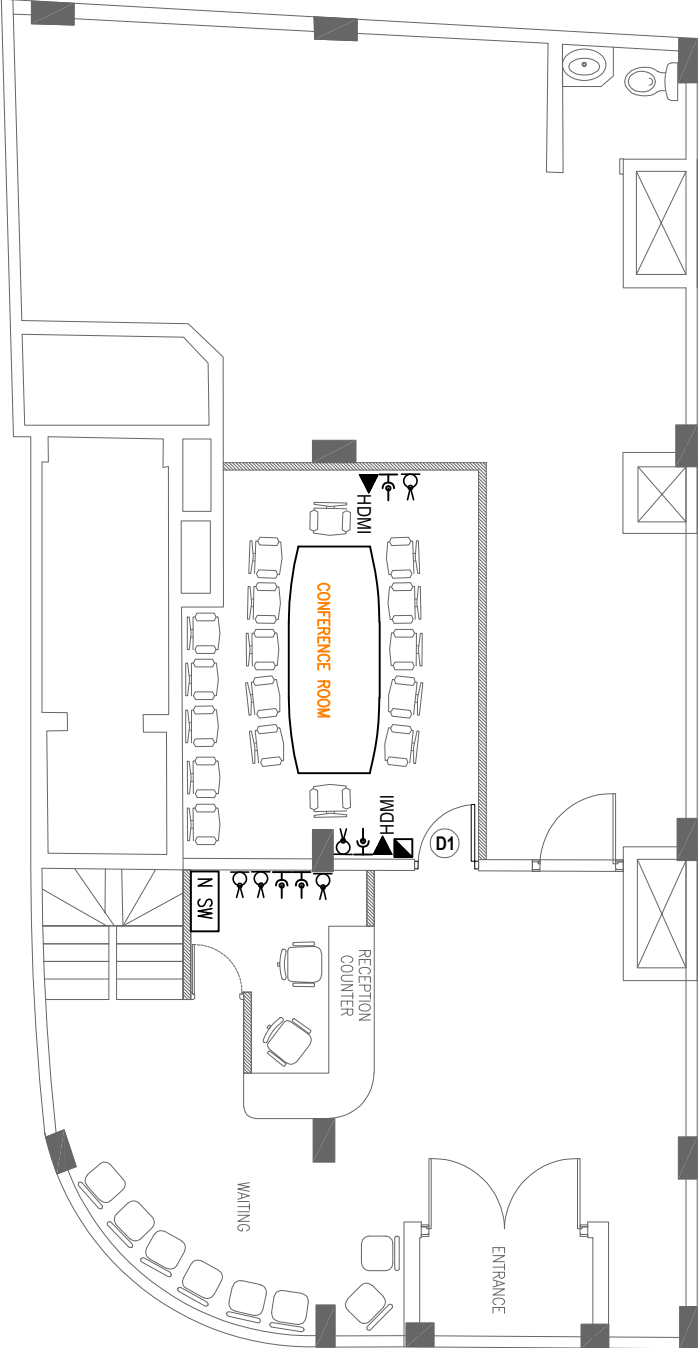


ELECTRICAL LEGEND

- ⊖ R/45 WALL OUTLET (DUAL PORT FACEPLATE) (+900MM FROM FFL)
- ▶ HDMI HDMI OUTLET (SINGLE GANG) (+300MM FROM FFL)
- ⊖ 13A WALL SOCKET OUTLET (SINGLE GANG) (+300MM FROM FFL)
- ⊖ 13A WALL SOCKET OUTLET (DOUBLE GANG) (+1200MM FROM FFL)
- ▣ SUB D-BOARD (SURFACE MOUNTED)
- ⊖ PROPOSED NETWORK SWITCH (OUT OF SCOPE)

H.REAL GROUND FLOOR ELECTRICAL & NETWORK PLAN


SCALE: 1 : 100

NOTE: ALL ELECTRICAL CABLES SHALL BE IN FLEXIBLE CONDUITS INSIDE THE DRYWALLS, AND IN PVC TRUNKING ON EXISTING WALLS. PVC TRUNKING SHALL BE INSTALLED WITH CONSTRUCTION ADHESIVES.
 ALL NETWORK CABLES SHALL BE WIRED FROM PROPOSED NETWORK SWITCH LOCATION TO THE LOCATIONS SHOWN

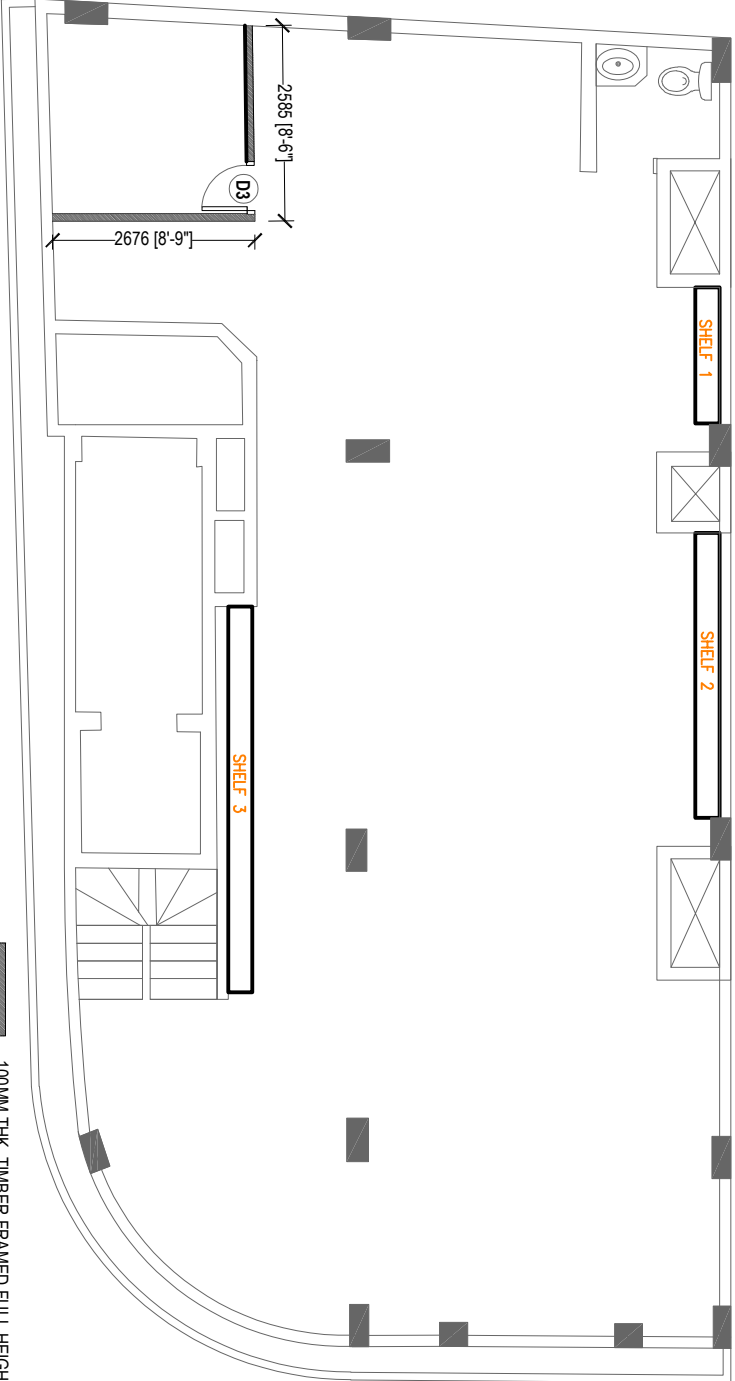

H.REAL FIRST FLOOR PARTITION LAYOUT
SCALE: 1 : 100

100MM THK. TIMBER FRAMED FULL HEIGHT
 GYPSUM PARTITION 2400-3000mm HIGH

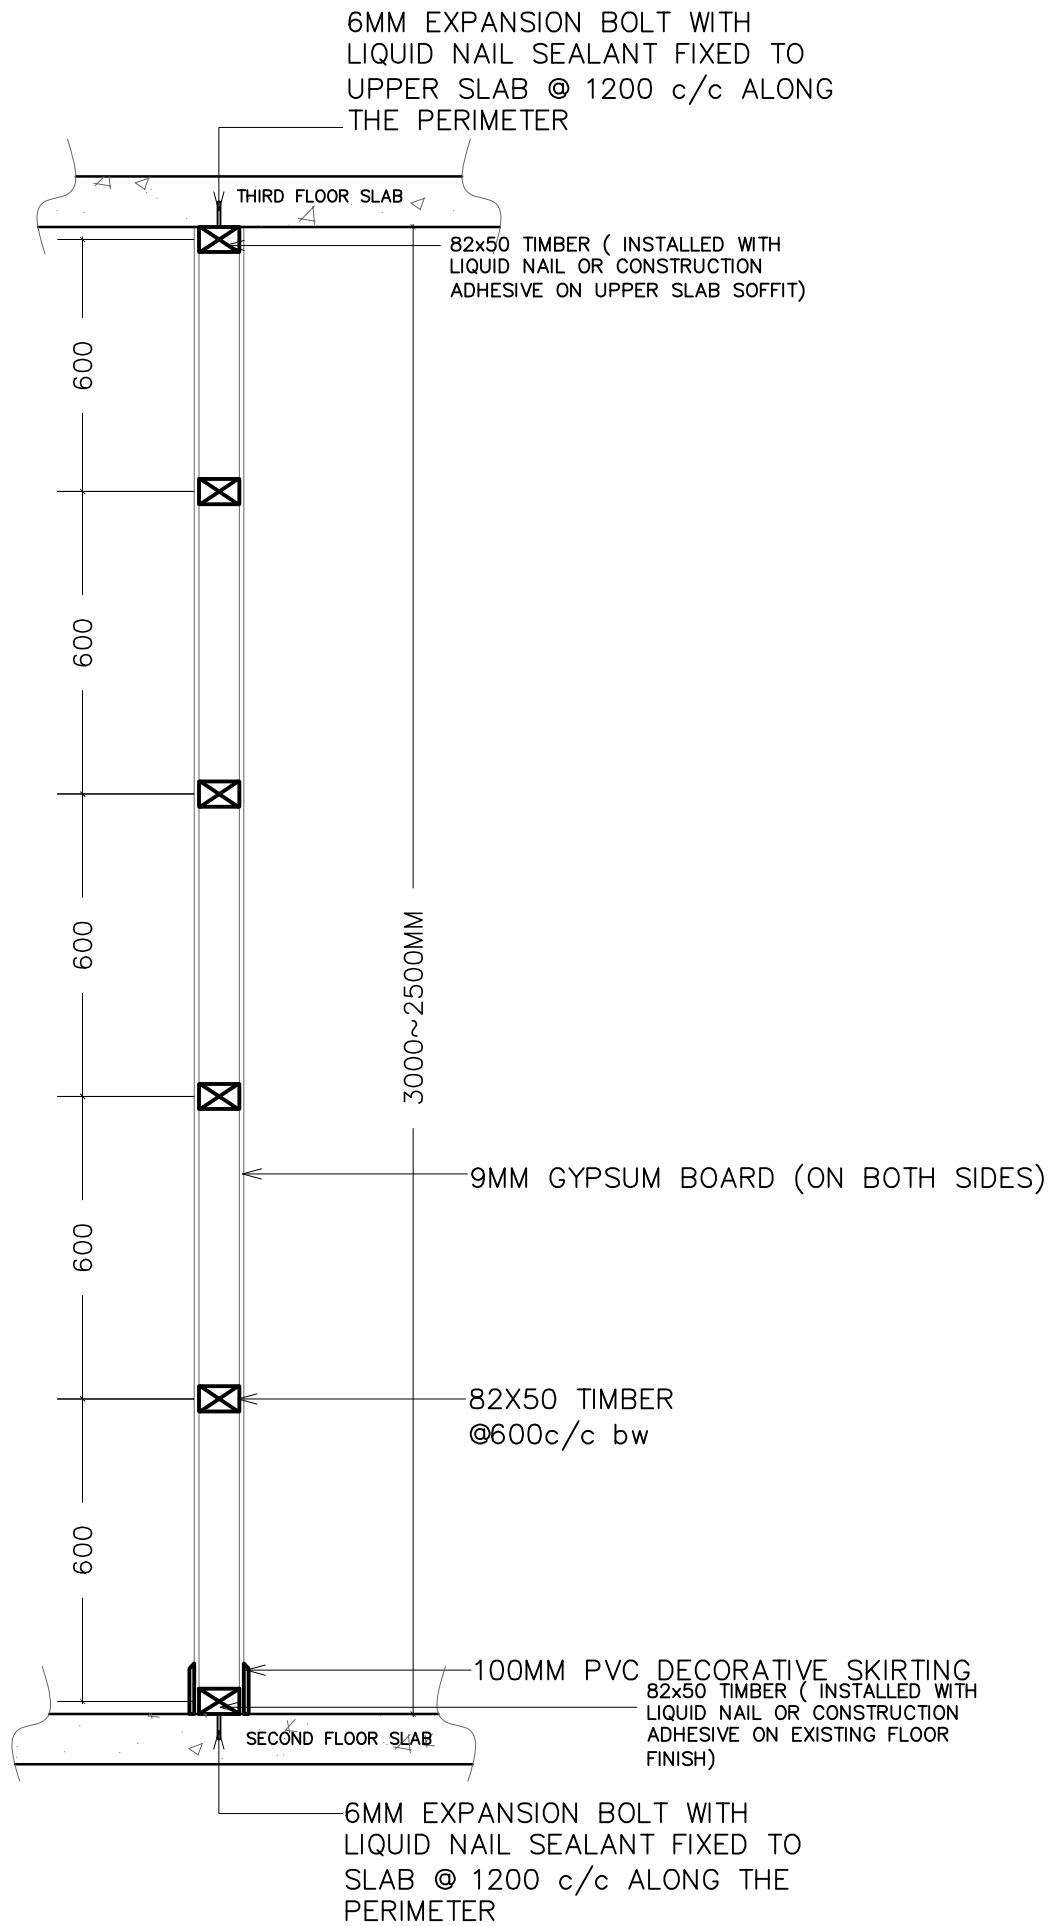

TYPICAL INTERIOR DRYWALL SECTIONAL VIEW


SCALE: 1 : 15

SYMBOL	D1		VENTILATION AREA	
			1.36 sq.m	
ELEVATION	D3		VENTILATION AREA	
			1.36 sq.m	
REQUIRED	QUANTITY	06	02	06
	LOCATION	GF	GF	GF
JAMBS	MATERIAL	TREATED TIMBER		TREATED TIMBER
	FINISH	PLAIN PAINTED SEMI GLOSS FINISH		PLAIN PAINTED SEMI GLOSS FINISH
PANEL	MATERIAL	SOLID TREATED TIMBER		SOLID TREATED TIMBER
	FINISH	PLAIN PAINTED SEMI GLOSS FINISH		PLAIN PAINTED SEMI GLOSS FINISH
CASING	MATERIAL	DECORATIVE TREATED TIMBER		DECORATIVE TREATED TIMBER
	FINISH	PLAIN PAINTED SEMI GLOSS FINISH		PLAIN PAINTED SEMI GLOSS FINISH
HINGES	MATERIAL	STAINLESS STEEL		STAINLESS STEEL
	HANDLE SET & LOCK	TYPICAL HANDLE SET WITH LATCH UNIT		TYPICAL HANDLE SET WITH LATCH UNIT
CLOSER		-		-
STOPPER/HOLDER		TYPICAL WALL MOUNT		TYPICAL WALL MOUNT
NOTES		-		-

FINISHED FLOOR LEVEL				
----------------------	--	--	--	--


H.REAL GROUND & 1ST FLOOR DW SCHEDULE

SCALE: 1 : 50

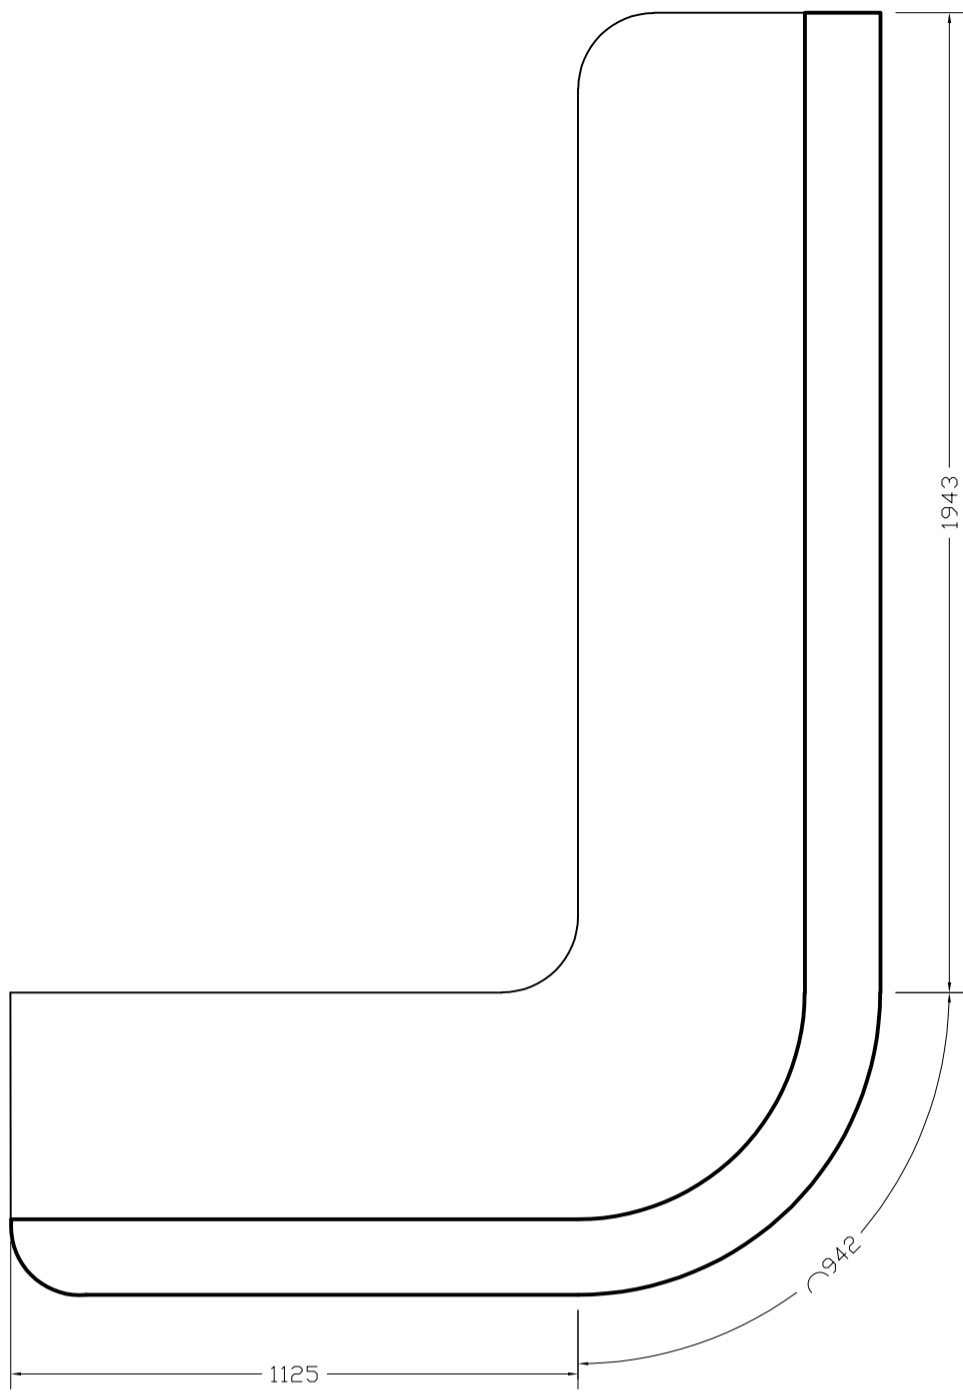


RECEPTION COUNTER PLAN

1:15

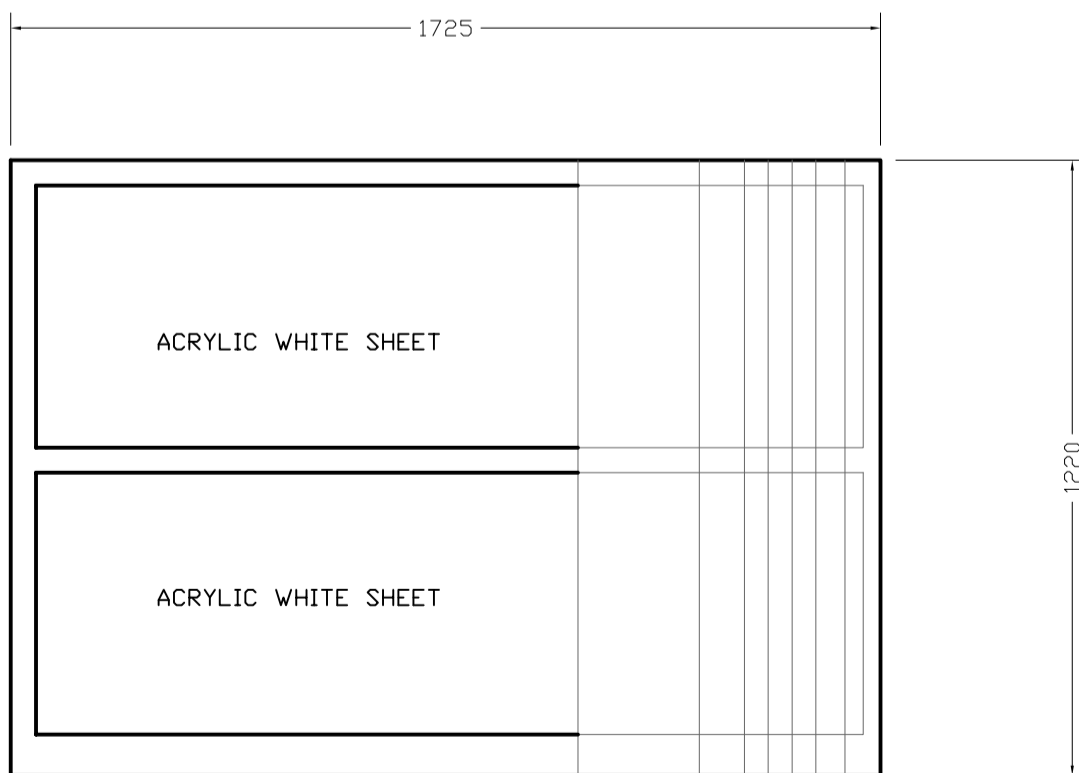


NARROW FRONT ELEVATION


1:15

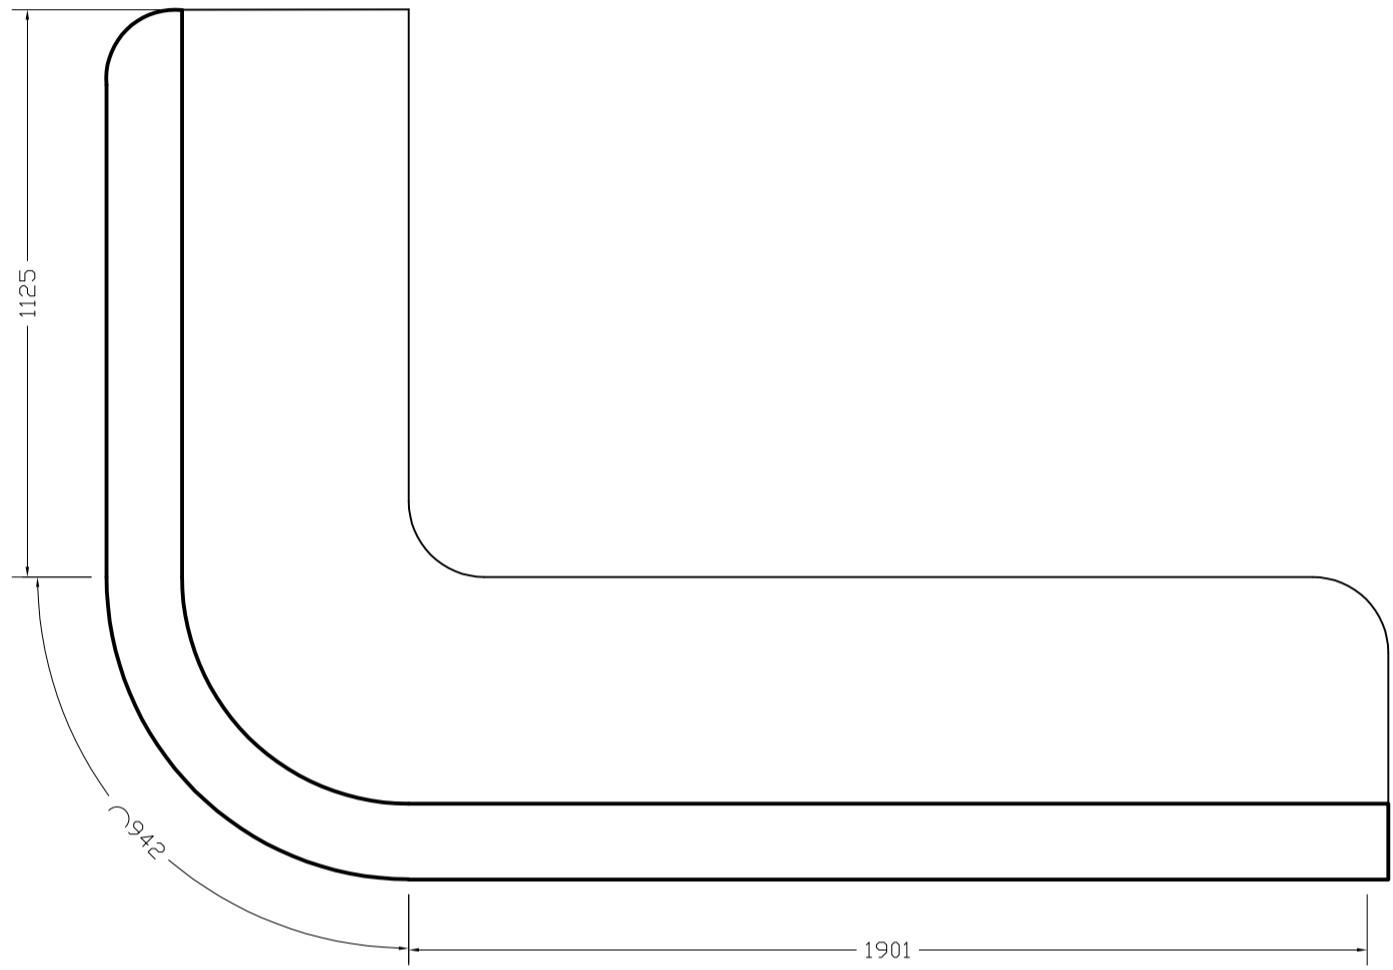

RECEPTION COUNTER PLAN 1:15

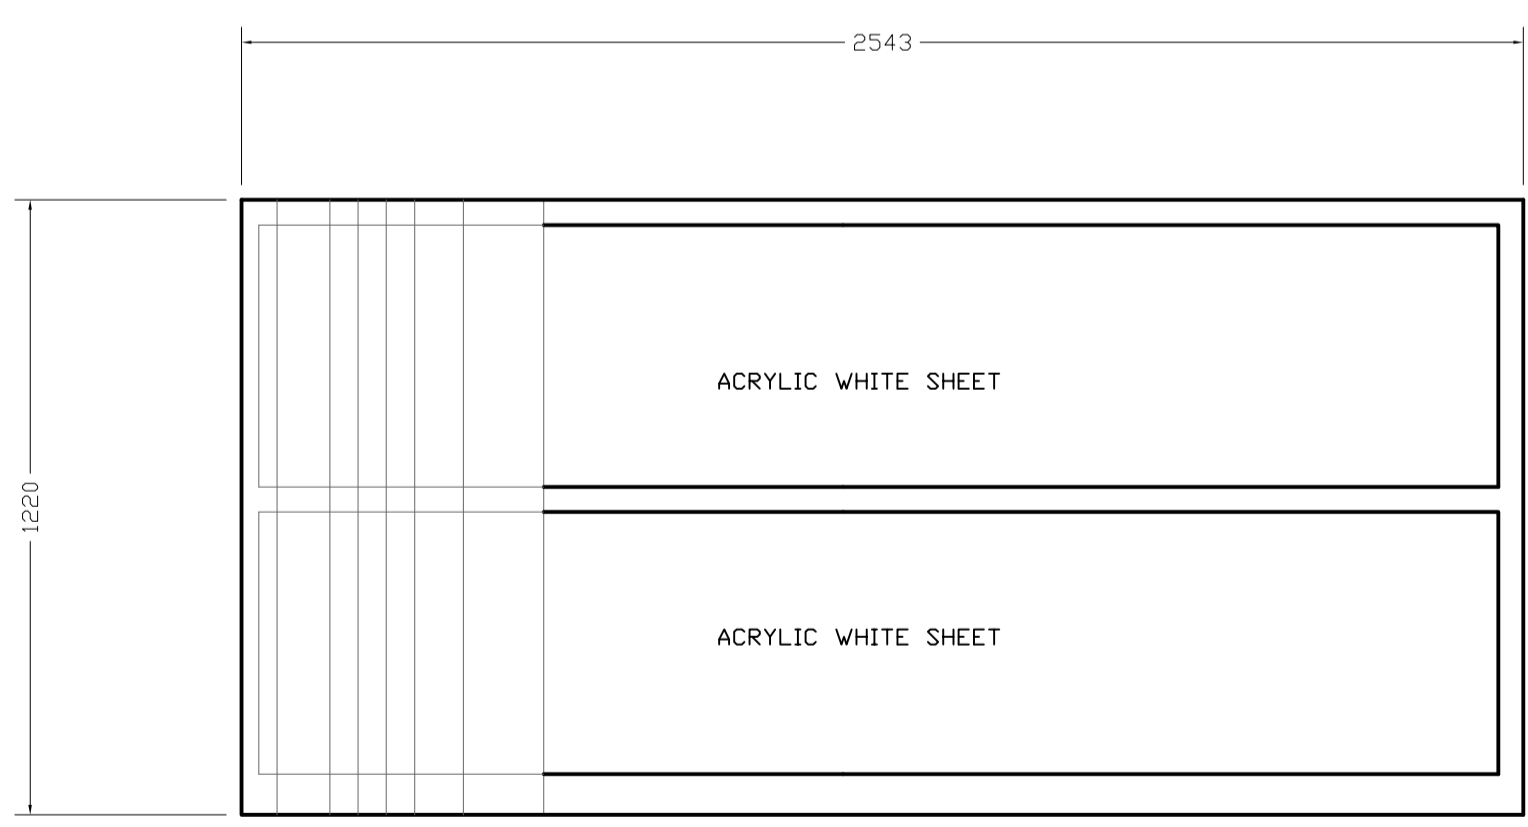



WIDE FRONT ELEVATION 1:15

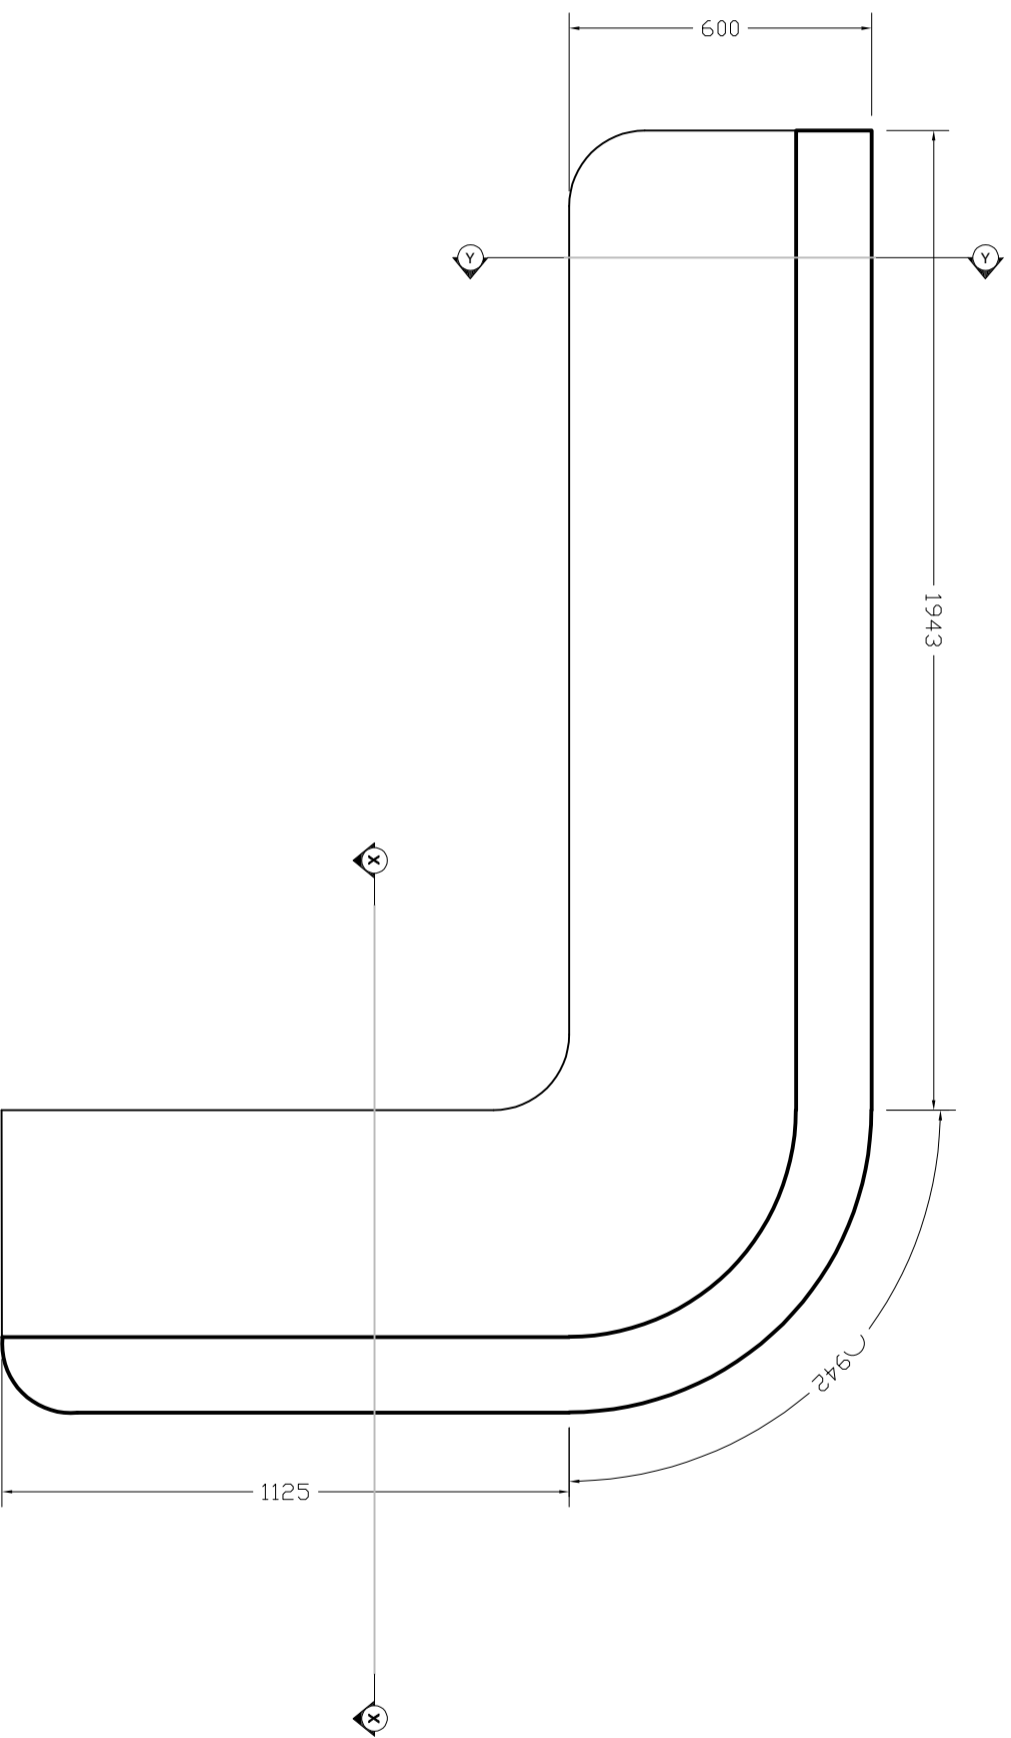



RECEPTION COUNTER PLAN

1:15

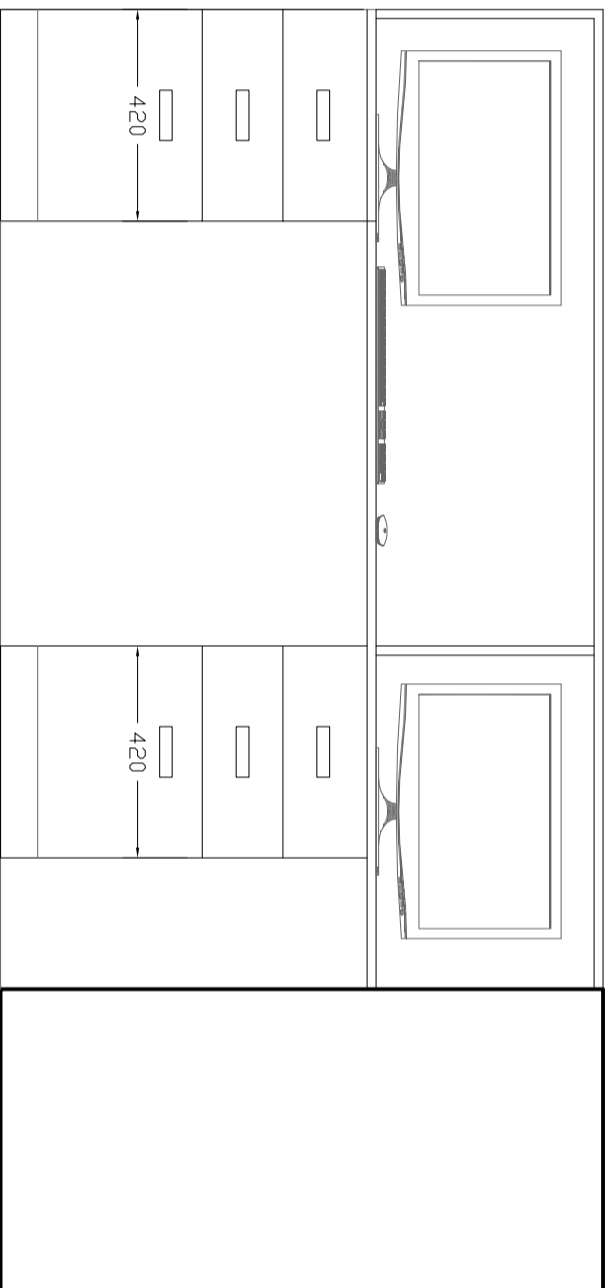


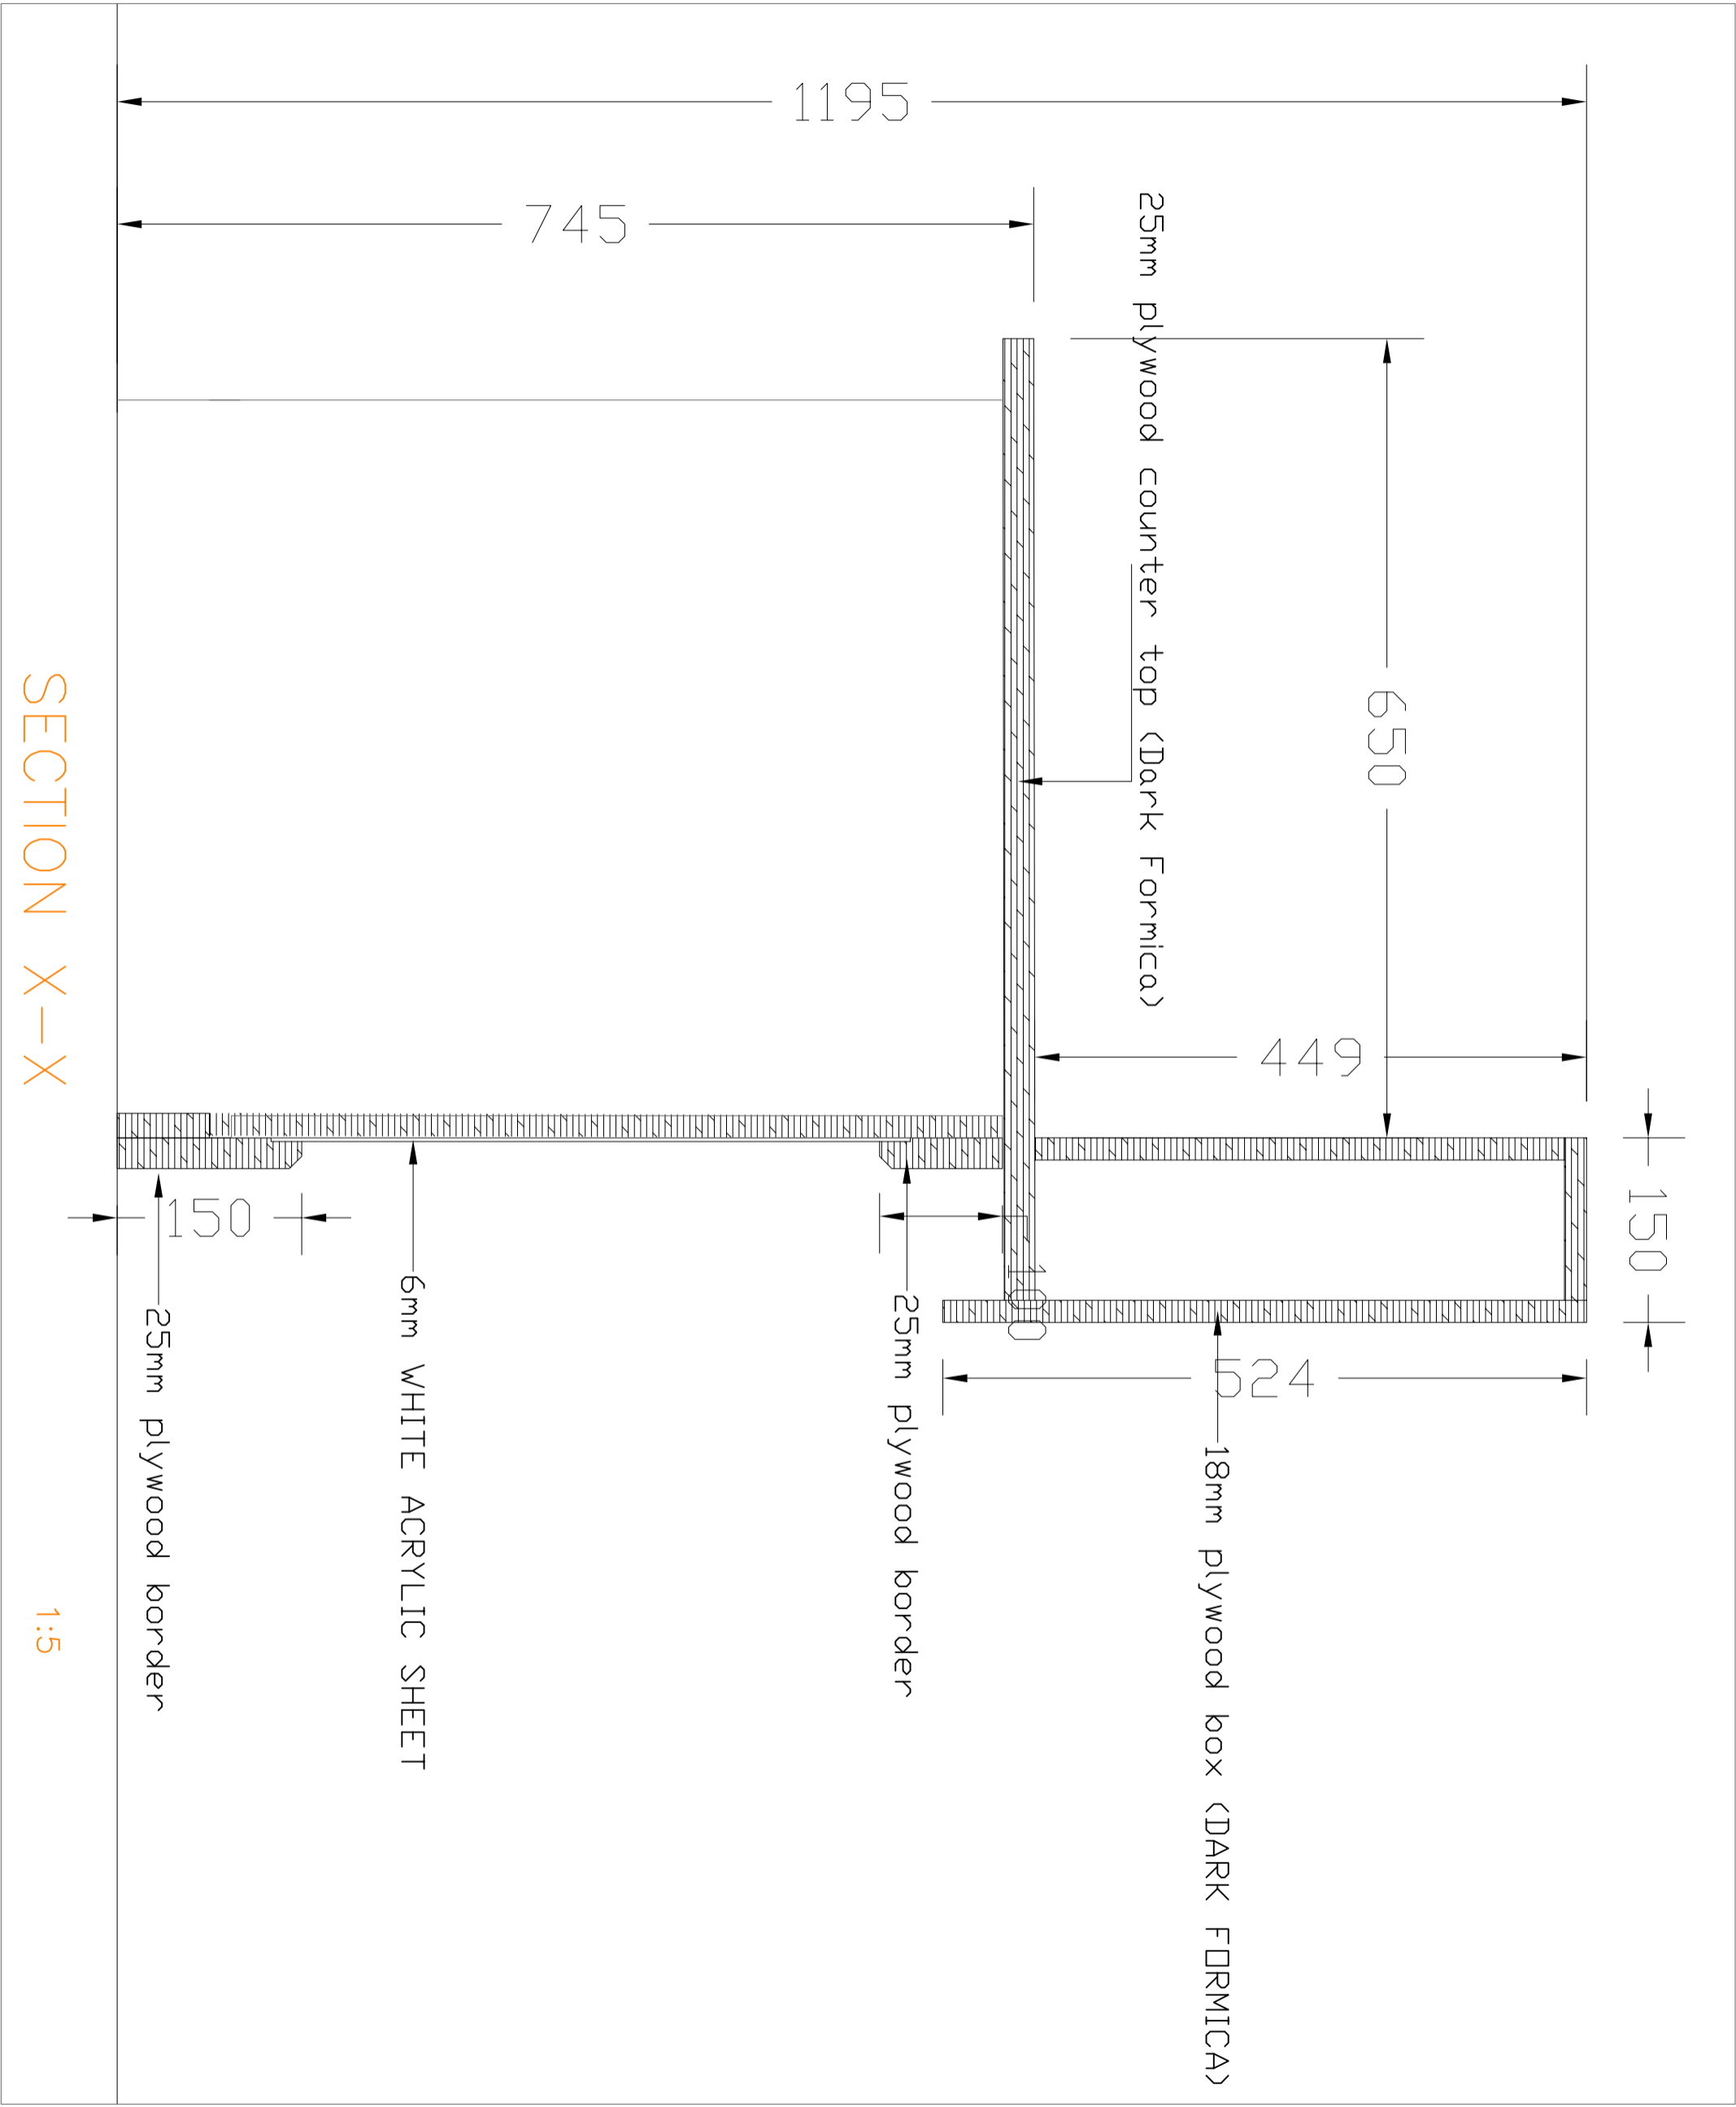

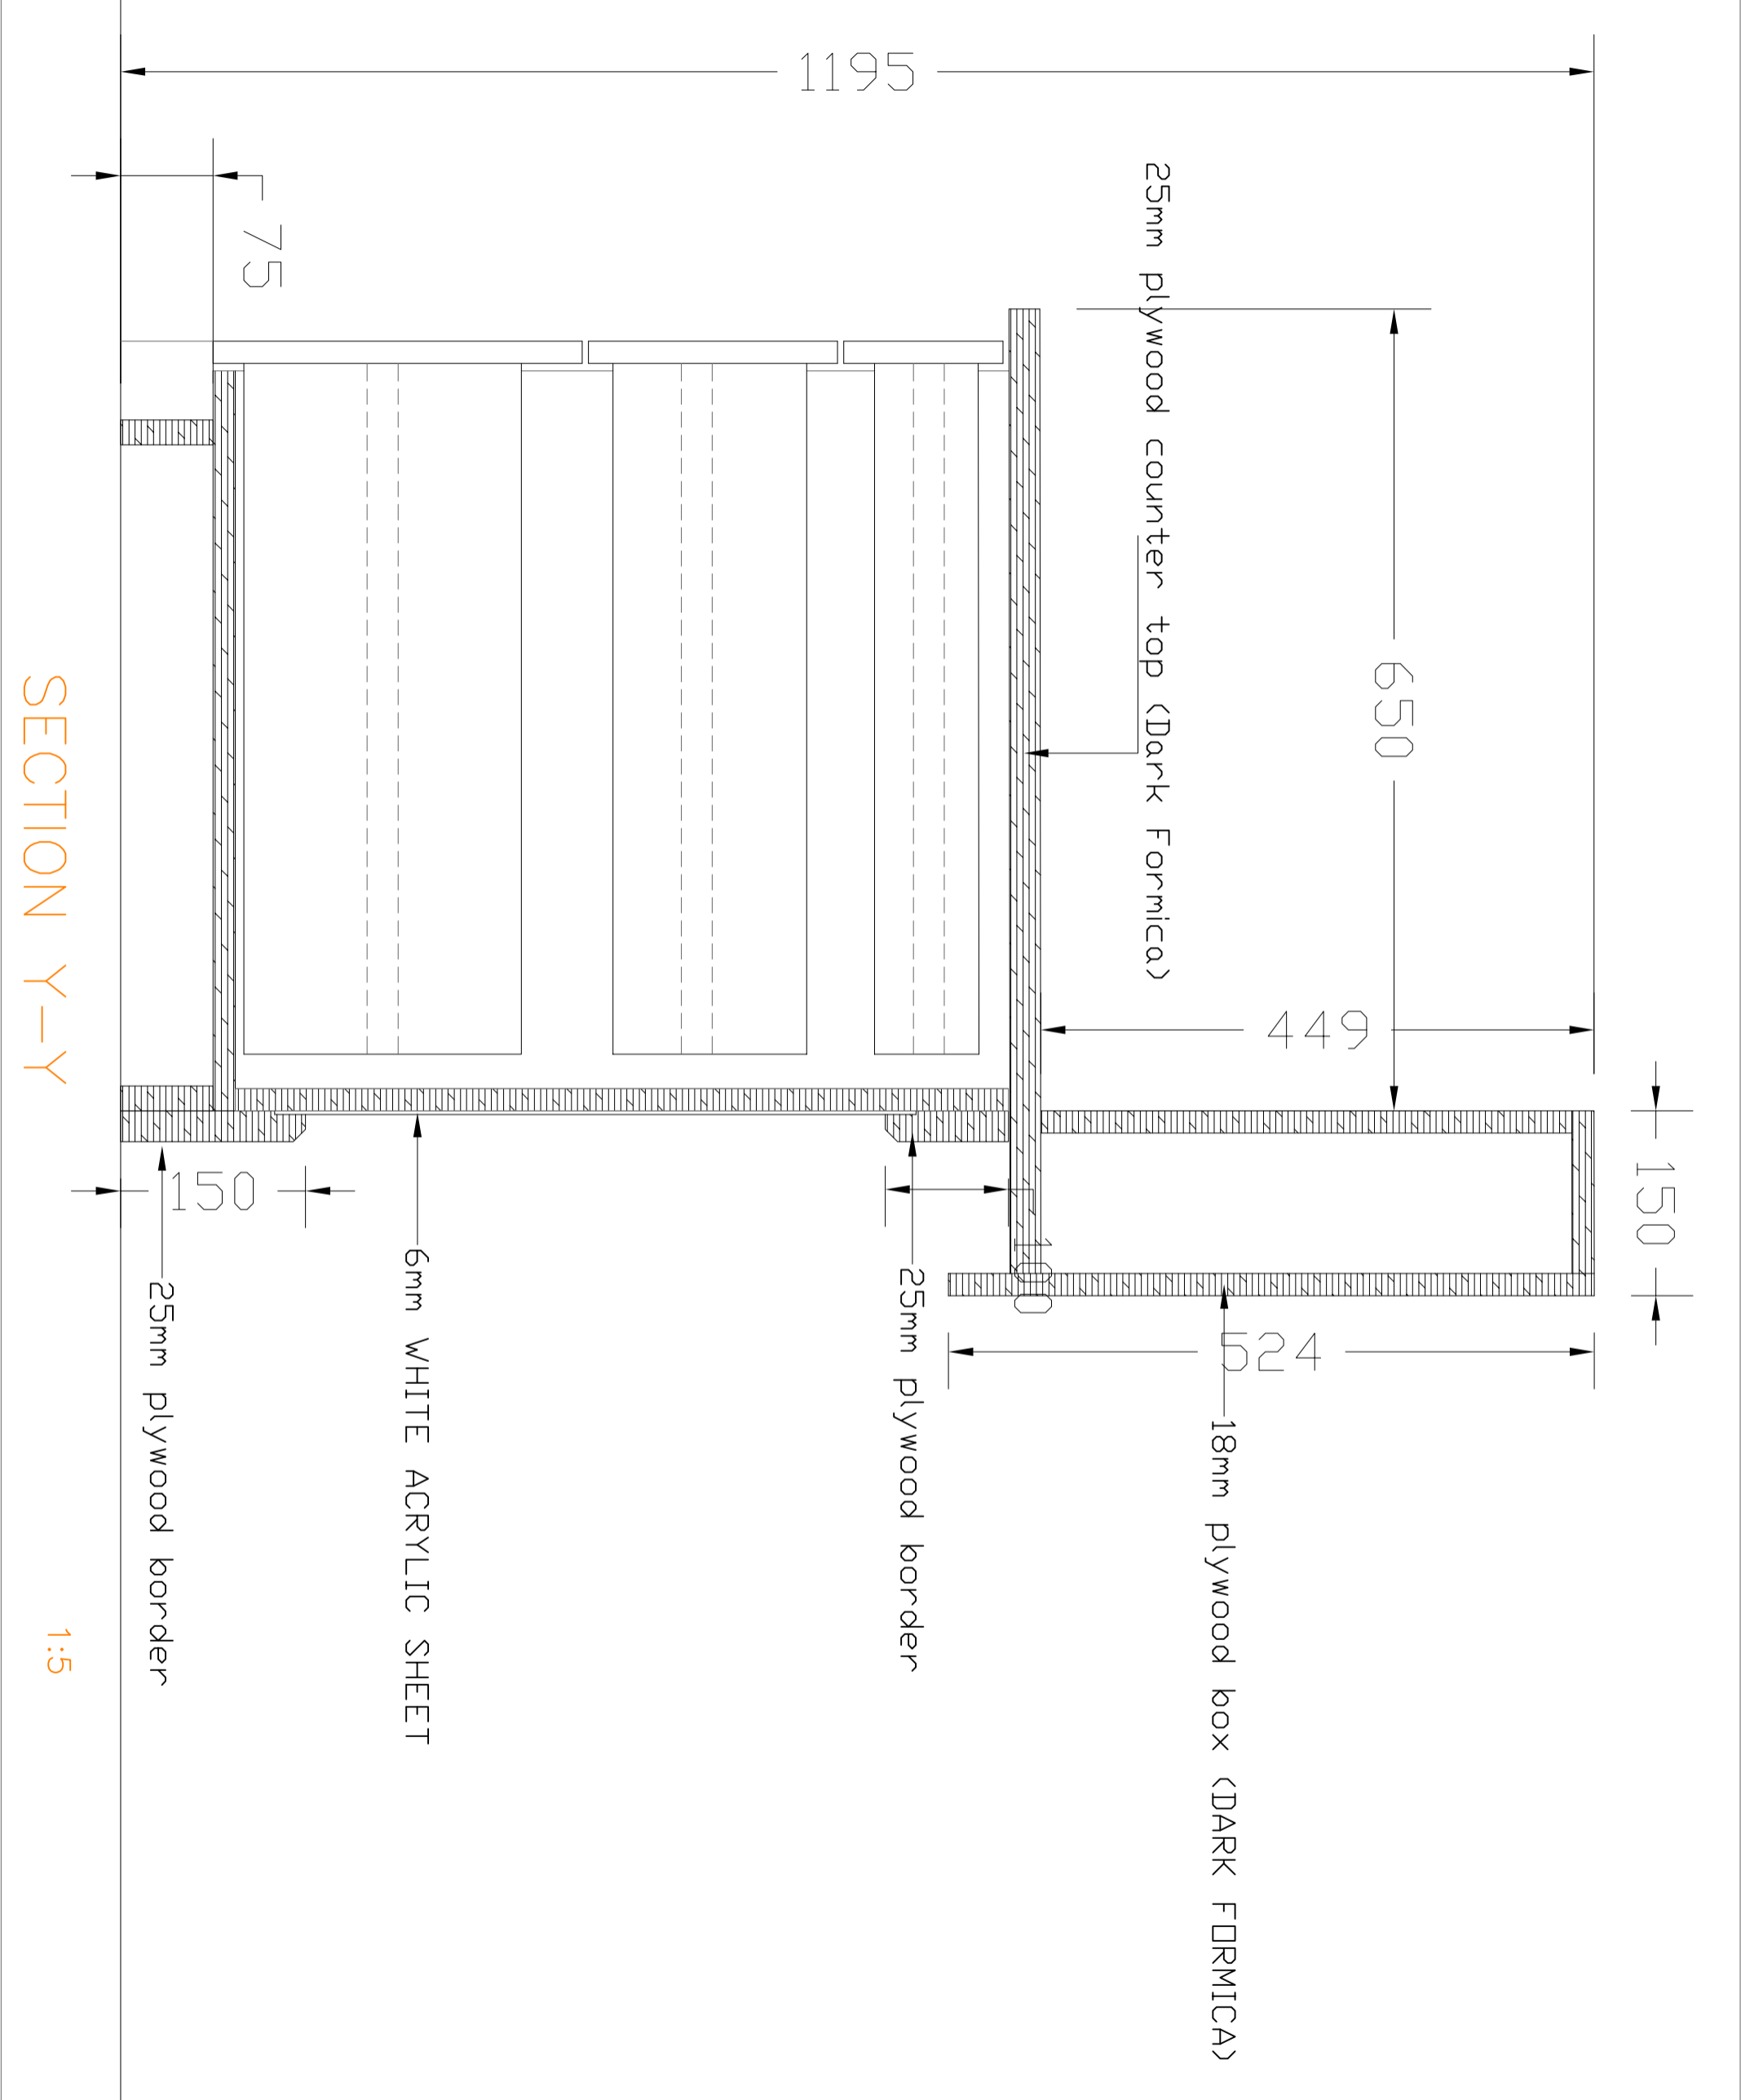


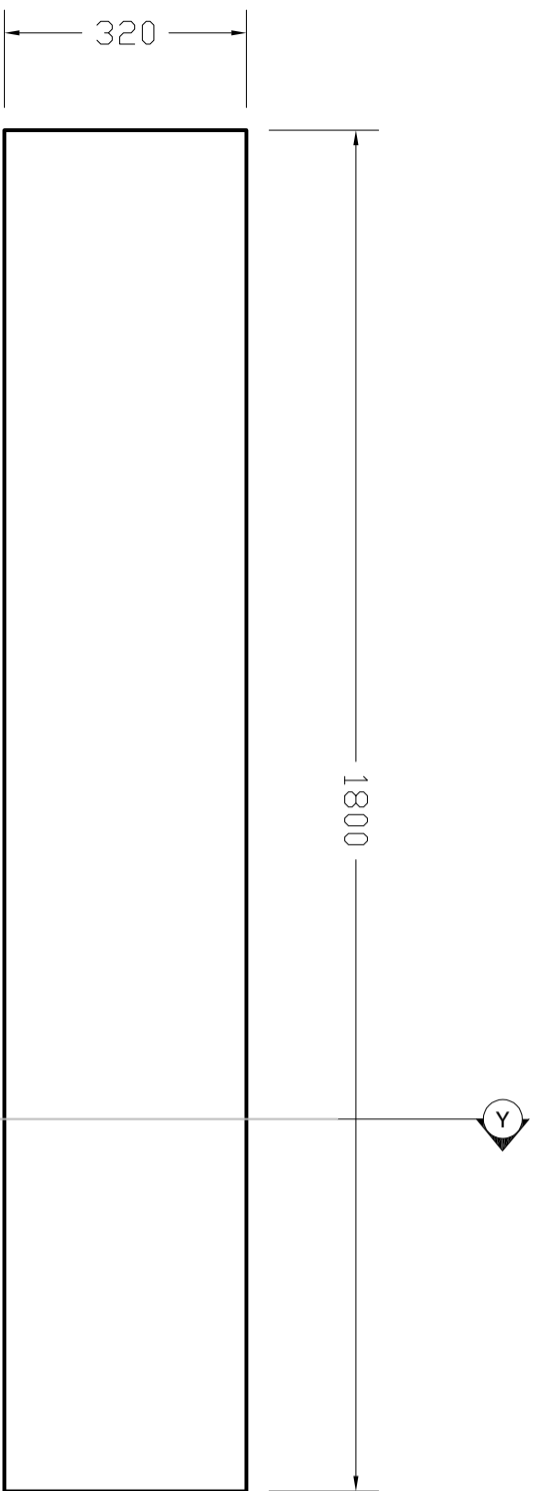

SHELF-1 PLAN
1:10

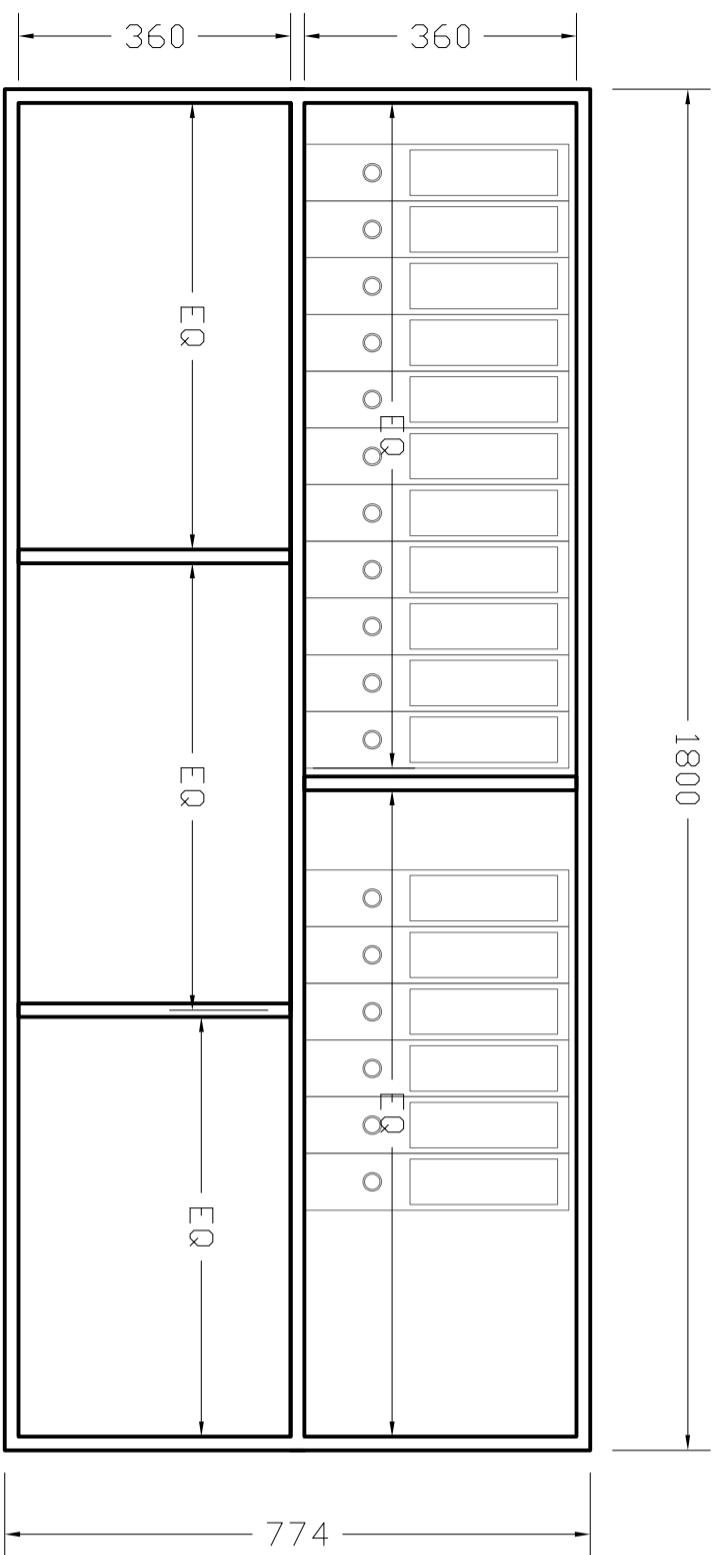


SHELF-1 FRONT ELEVATION
1:10

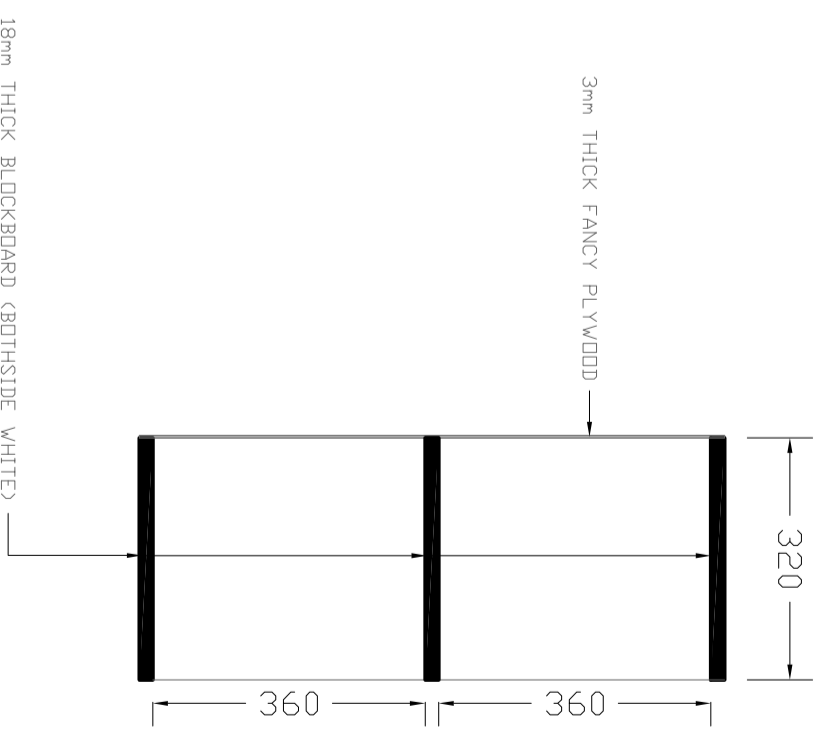


SHELF-1 SECTION Y-Y
1:10


SHELF-2 PLAN
1:15

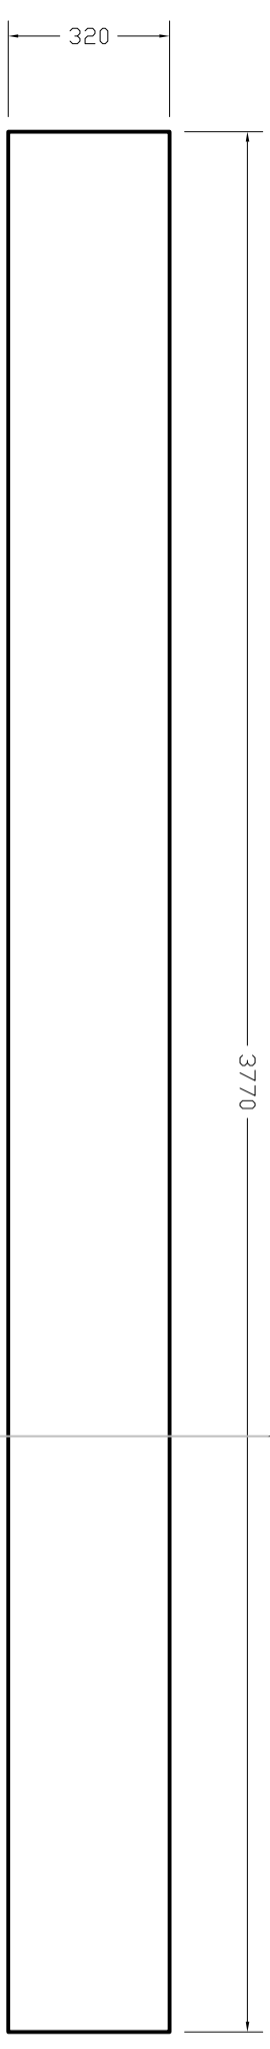


SHELF-2 FRONT ELEVATION
1:15

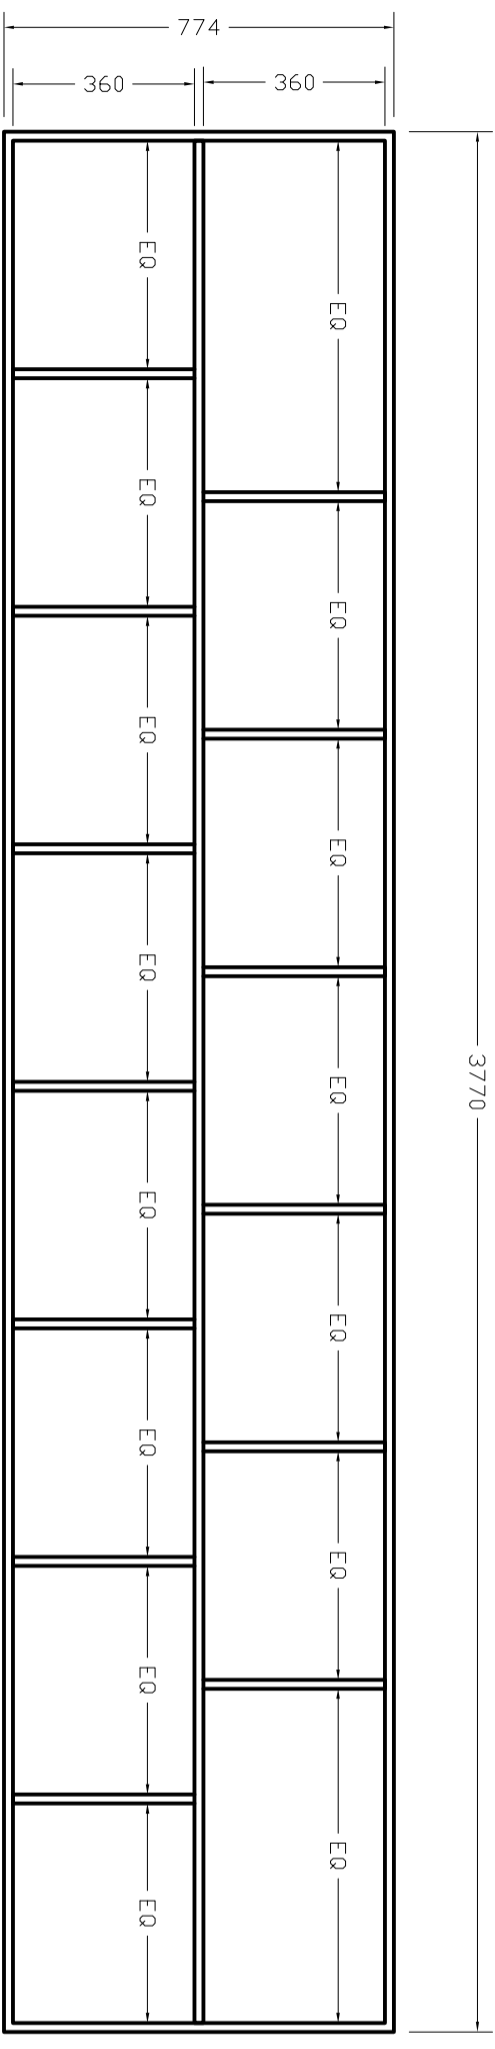


SHELF-2 SECTION Y-Y
1:15

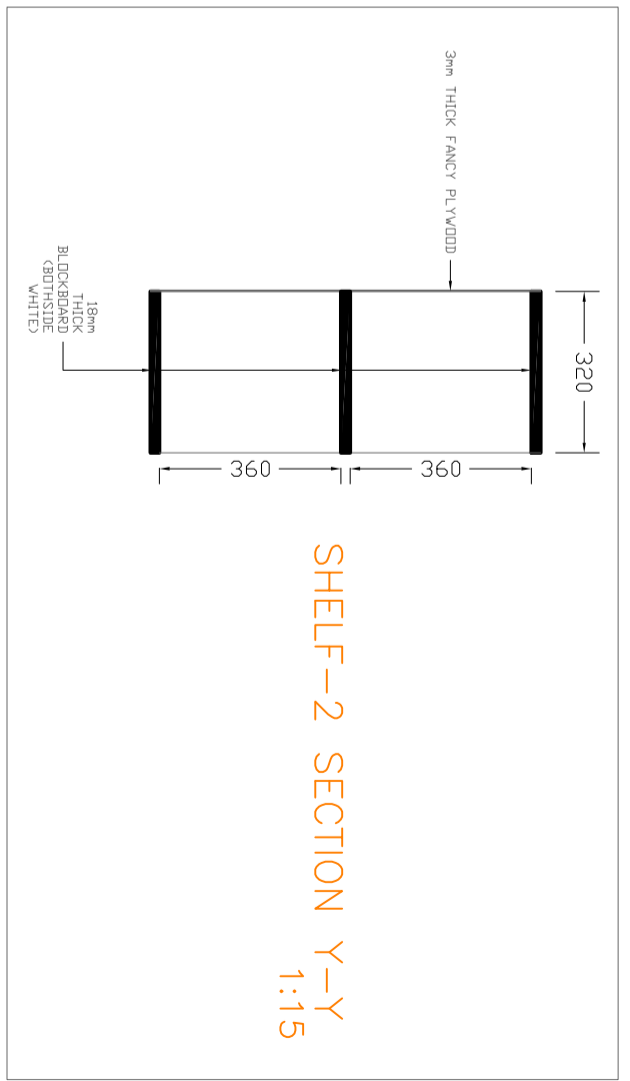


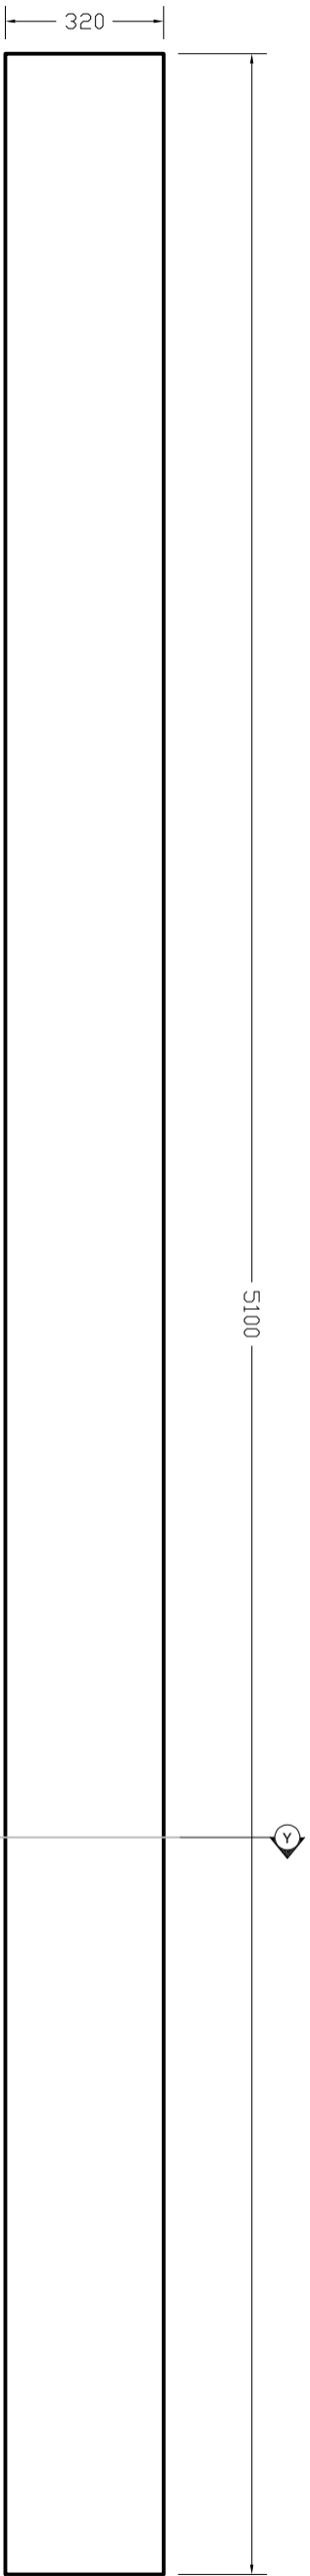

SHELF-3 PLAN
1:15

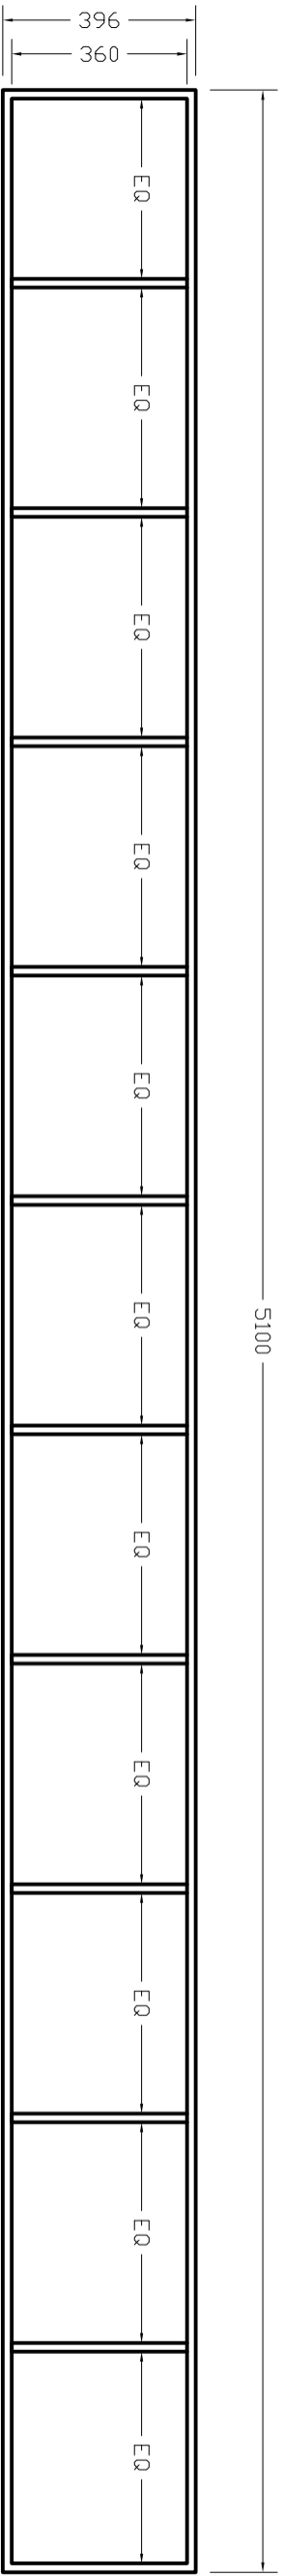

SHELF-3 FRONT ELEVATION
1:15

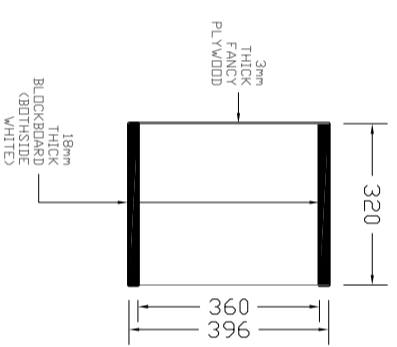

SHELF-3 SECTION Y-Y
1:10