

**CONSULTANCY FOR ARCHITECTURAL FIRM FOR THE DESIGNING  
AND PREPARATION OF DETAILED DRAWINGS, BOQS AND THE  
SUPERVISION OF THE REFURBISHMENTS OF POLYTECHNICS  
MALDIVES POLYTECHNIC, S.HITTHADHOO CAMPUS  
ARCHITECTURAL, STRUCTURAL & SERVICES DRAWINGS**


**SEPTEMBER 2021**

CONTRACT NO: MEERY/2021/GS-016


CLIENT : MINISTRY OF HIGHER EDUCATION

DESIGN BY

**ArchEng**  
s t u d i o  
Ma Fiyajahge, 1st floor, Male', Republic of Maldives  
admin@archeng.biz

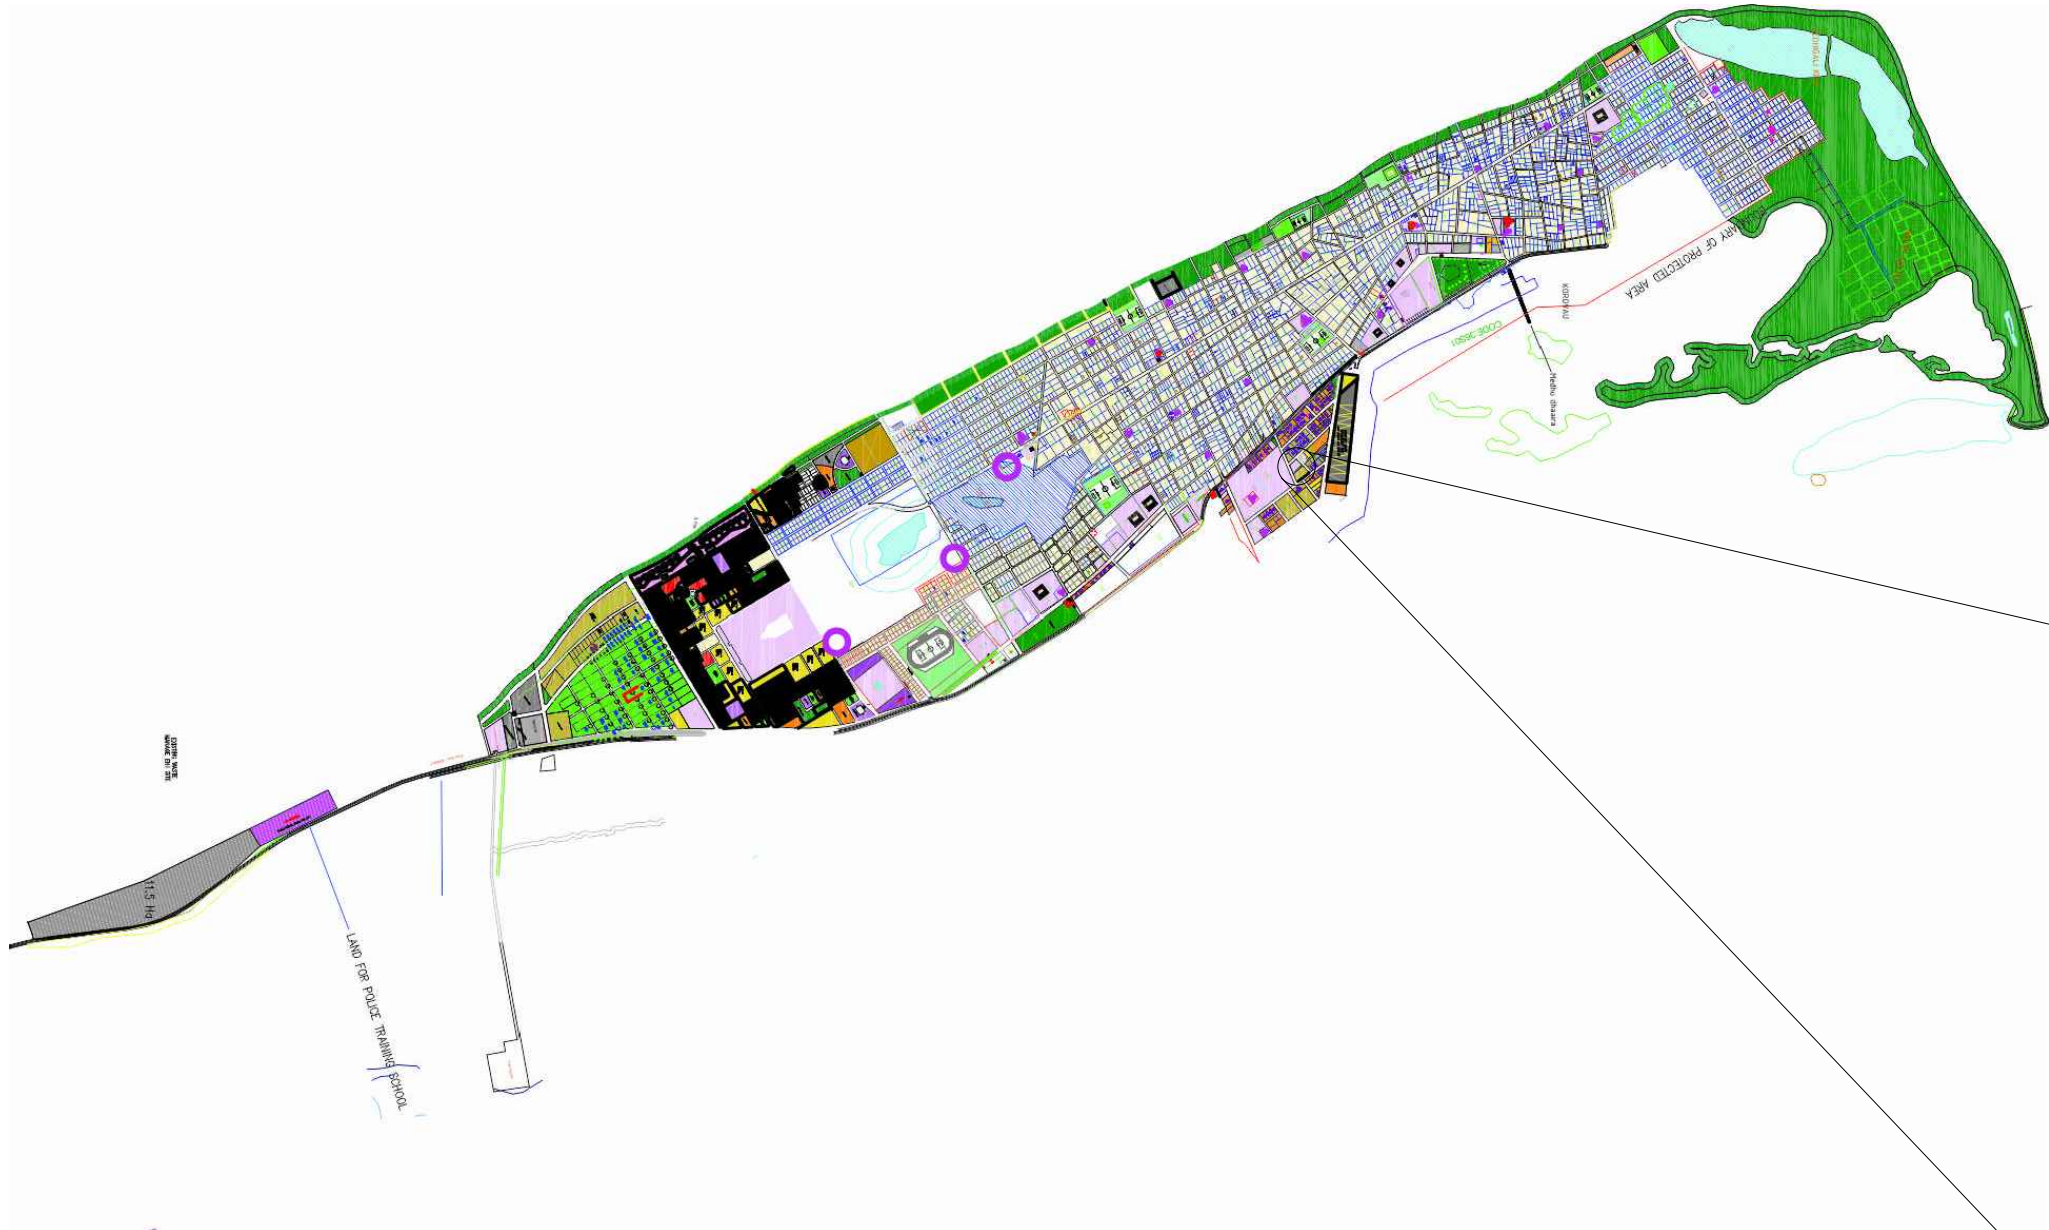

SOURCE : S.HITHADHOO LANDUSE PLAN,  
MINISTRY NATIONAL OF PLANNING, HOUSING AND  
INFRASTRUCTURE

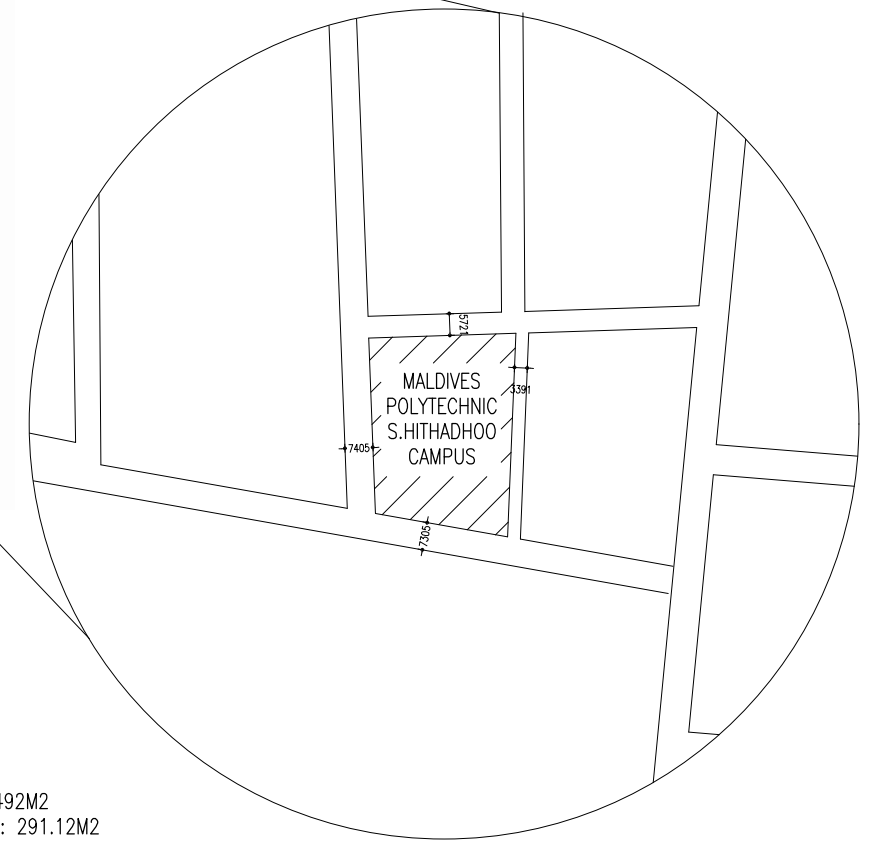

PLOT AREA :1492M2  
BUILDING AREA: 291.12M2

**LOCATION PLAN**  
SCALE 1:200


CONTRACTORS MUST  
CHECK ALL  
DIMENSIONS ON SITE  
BEFORE STARTING  
ANY WORK OR SHOP  
DRAWINGS. FIGURED  
DIMENSIONS TO TAKE  
PRECEDENCE OVER  
SCALE READINGS



REVISION:	ARCHITECT:	PROJECT:	MALDIVES POLYTECHNIC, SEENU. HITHADHOO CAMPUS
	ENGINEER:	LOCATION:	SEENU. HITHADHOO
	ARCHITECTURAL CHECKER:	DRAWING TITLE:	AS GIVEN
	STRUCTURAL CHECKER:	CLIENT:	MINISTRY OF HIGHER EDUCATION
	DRAWN BY: AISHATH HAMRA	SCALE: AS GIVEN	DIMENSION: MM
		DATE: SEPTMBER 2021	

**A-01**

DWG NO  
PROJECT NO: 21-001

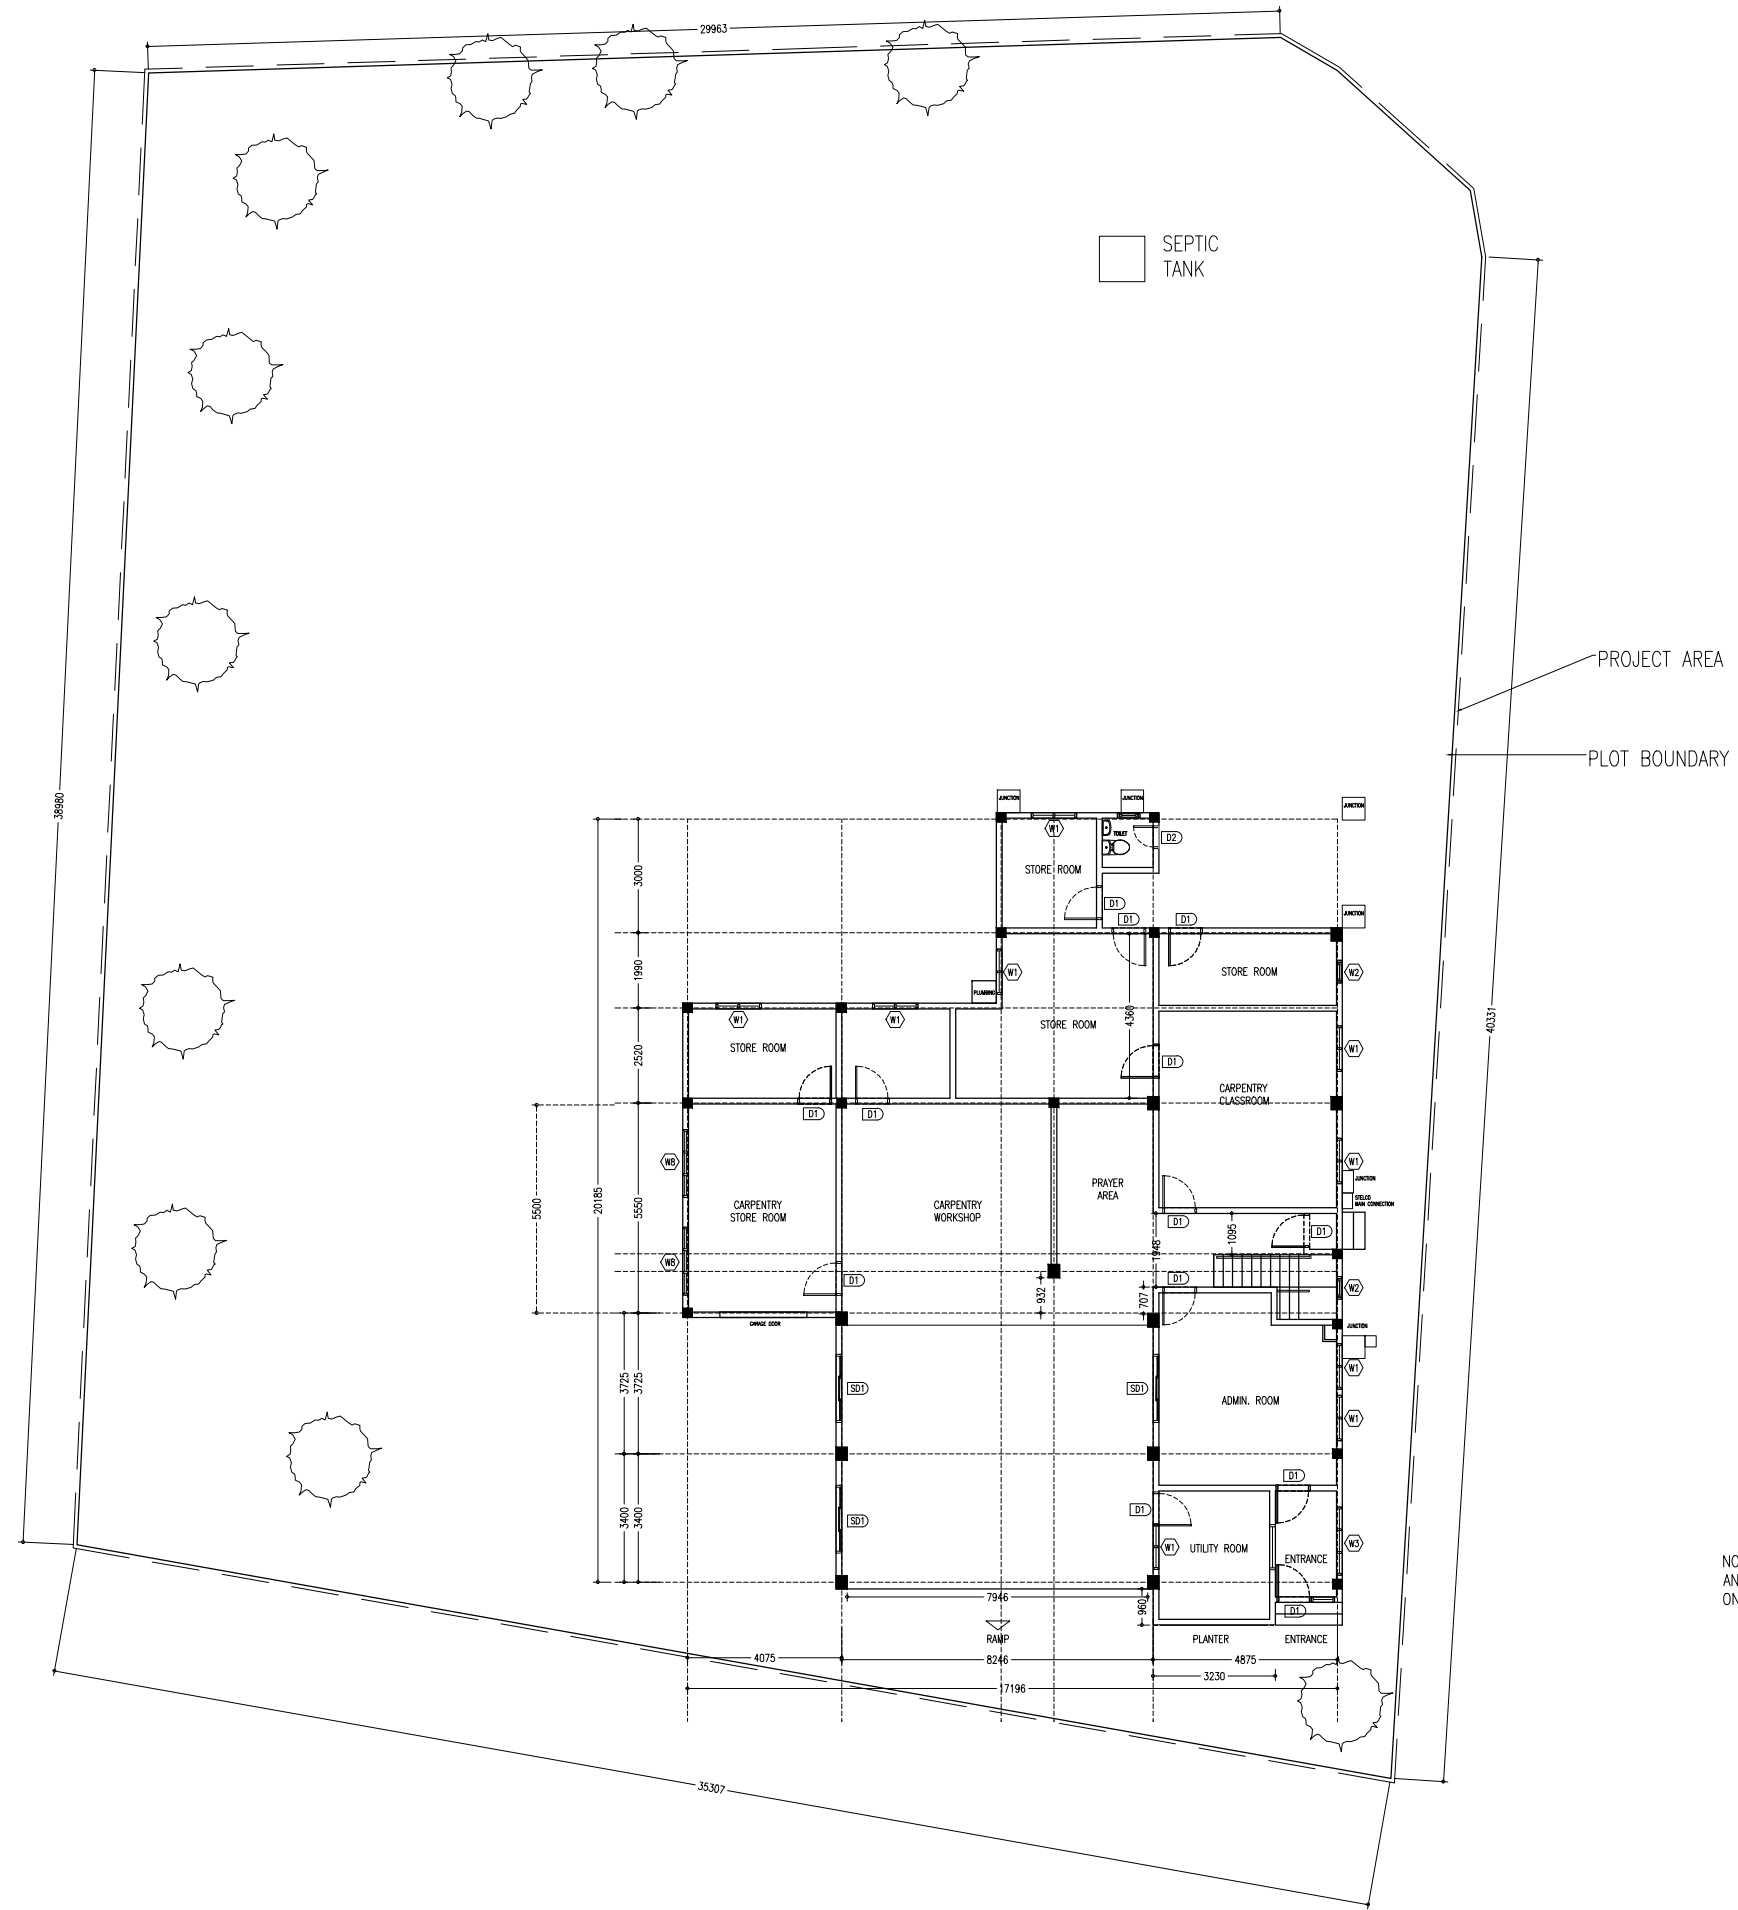

**SITE PLAN**  
SCALE 1:200

CONTRACTORS MUST CHECK ALL DIMENSIONS ON SITE BEFORE STARTING ANY WORK OR SHOP DRAWINGS. FIGURED DIMENSIONS TO TAKE PRECEDENCE OVER SCALE READINGS




REVISION:	ARCHITECT:	PROJECT:	MALDIVES POLYTECHNIC, SEENU. HITHADHOO CAMPUS
	ENGINEER:	LOCATION:	SEENU. HITHADHOO
	ARCHITECTURAL CHECKER:	DRAWING TITLE:	AS GIVEN
	STRUCTURAL CHECKER:	CLIENT:	MINISTRY OF HIGHER EDUCATION
	DRAWN BY: AISHATH HAMRA	SCALE: AS GIVEN	DIMENSION: MM
		DATE: SEPTEMBER 2021	PROJECT NO: 21-001




**A-02**

CONCEPT AND DESIGN IN THIS DRAWING ARE THE PROPERTIES OF ARCHENG STUDIO PVT LTD. UNAUTHORIZED USE OR REPRODUCTION OF PART OF THE DESIGN, DRAWINGS OR CONCEPT TO USE IN OTHER PROJECTS OR SITES OTHER THAN SPECIFIED ON THIS DRAWING IS PROHIBITED

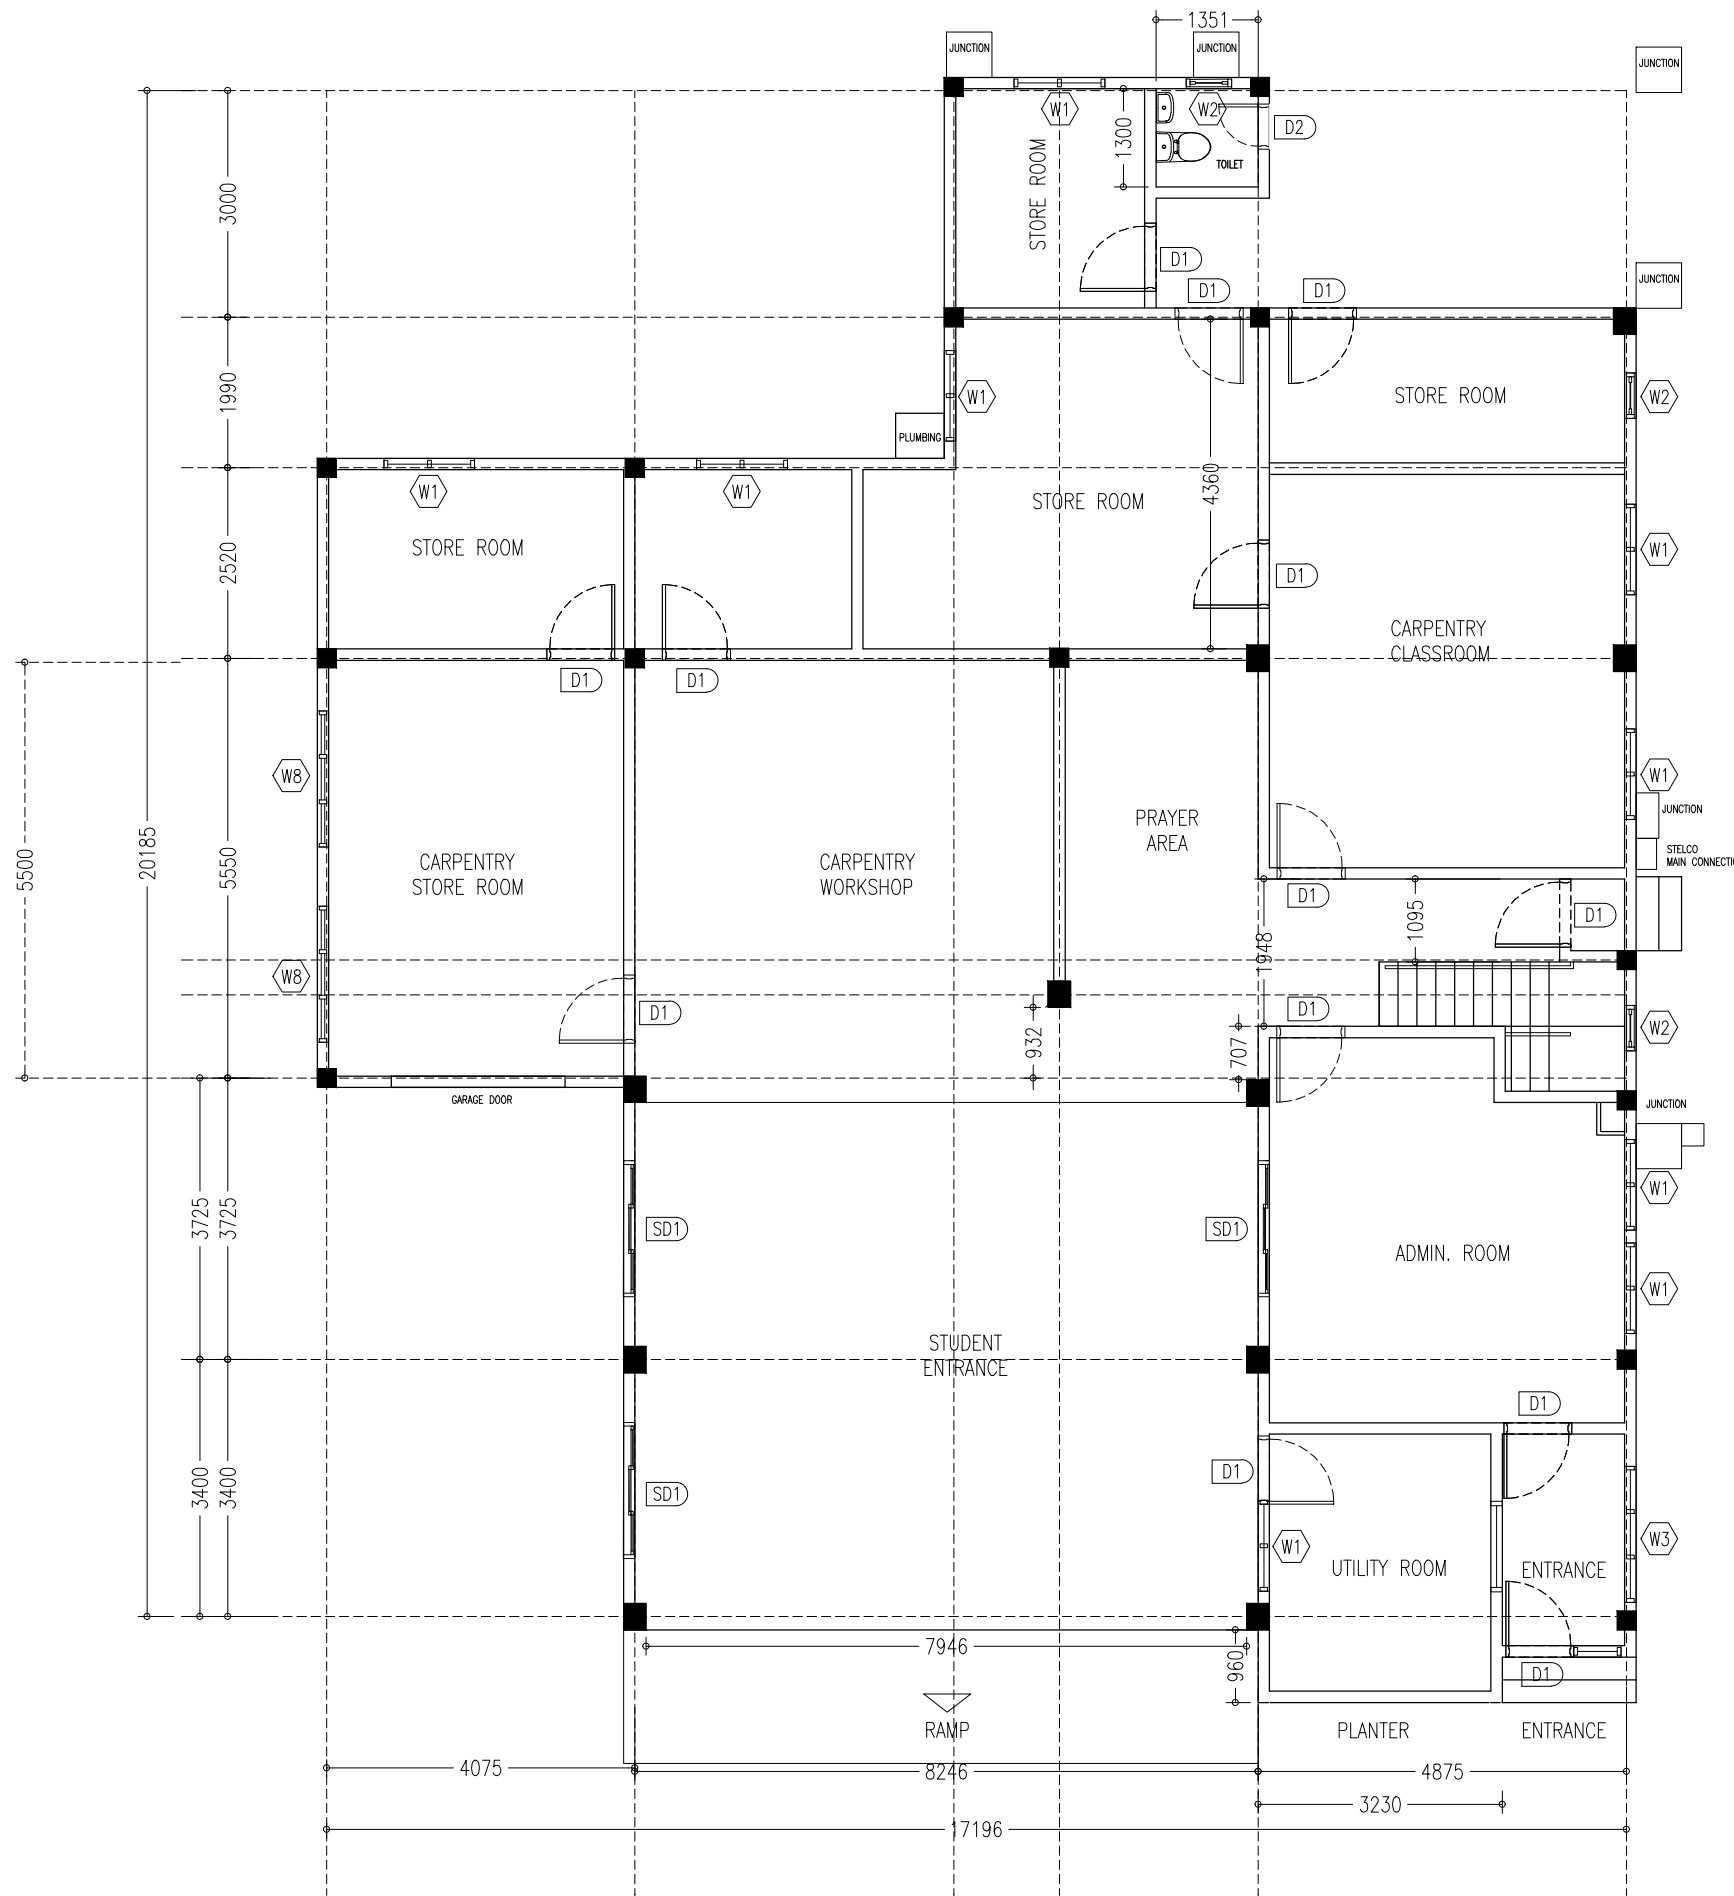

**GROUND FLOOR PLAN**  
SCALE 1:100


CONTRACTORS MUST CHECK ALL DIMENSIONS ON SITE BEFORE STARTING ANY WORK OR SHOP DRAWINGS. FIGURED DIMENSIONS TO TAKE PRECEDENCE OVER SCALE READINGS

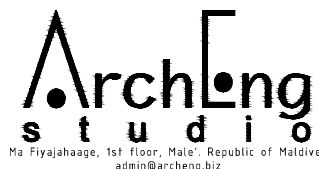

REVISION:	ARCHITECT:	PROJECT:	MALDIVES POLYTECHNIC, SEENU. HITHADHOO CAMPUS
	ENGINEER:	LOCATION:	SEENU. HITHADHOO
	ARCHITECTURAL CHECKER:	DRAWING TITLE:	AS GIVEN
	STRUCTURAL CHECKER:	CLIENT:	MINISTRY OF HIGHER EDUCATION
	DRAWN BY: AISHATH HAMRA	SCALE: AS GIVEN	DIMENSION: MM
		DATE: SEPTEMBER 2021	

**A-03**  
DWG NO  
PROJECT NO: 21-001

CONCEPT AND DESIGN IN THIS DRAWING ARE THE PROPERTIES OF ARCHENG STUDIO PVT LTD. UNAUTHORIZED USE OR REPRODUCTION OF PART OF THE DESIGN, DRAWINGS OR CONCEPT TO USE IN OTHER PROJECTS OR SITES OTHER THAN SPECIFIED ON THIS DRAWING IS PROHIBITED

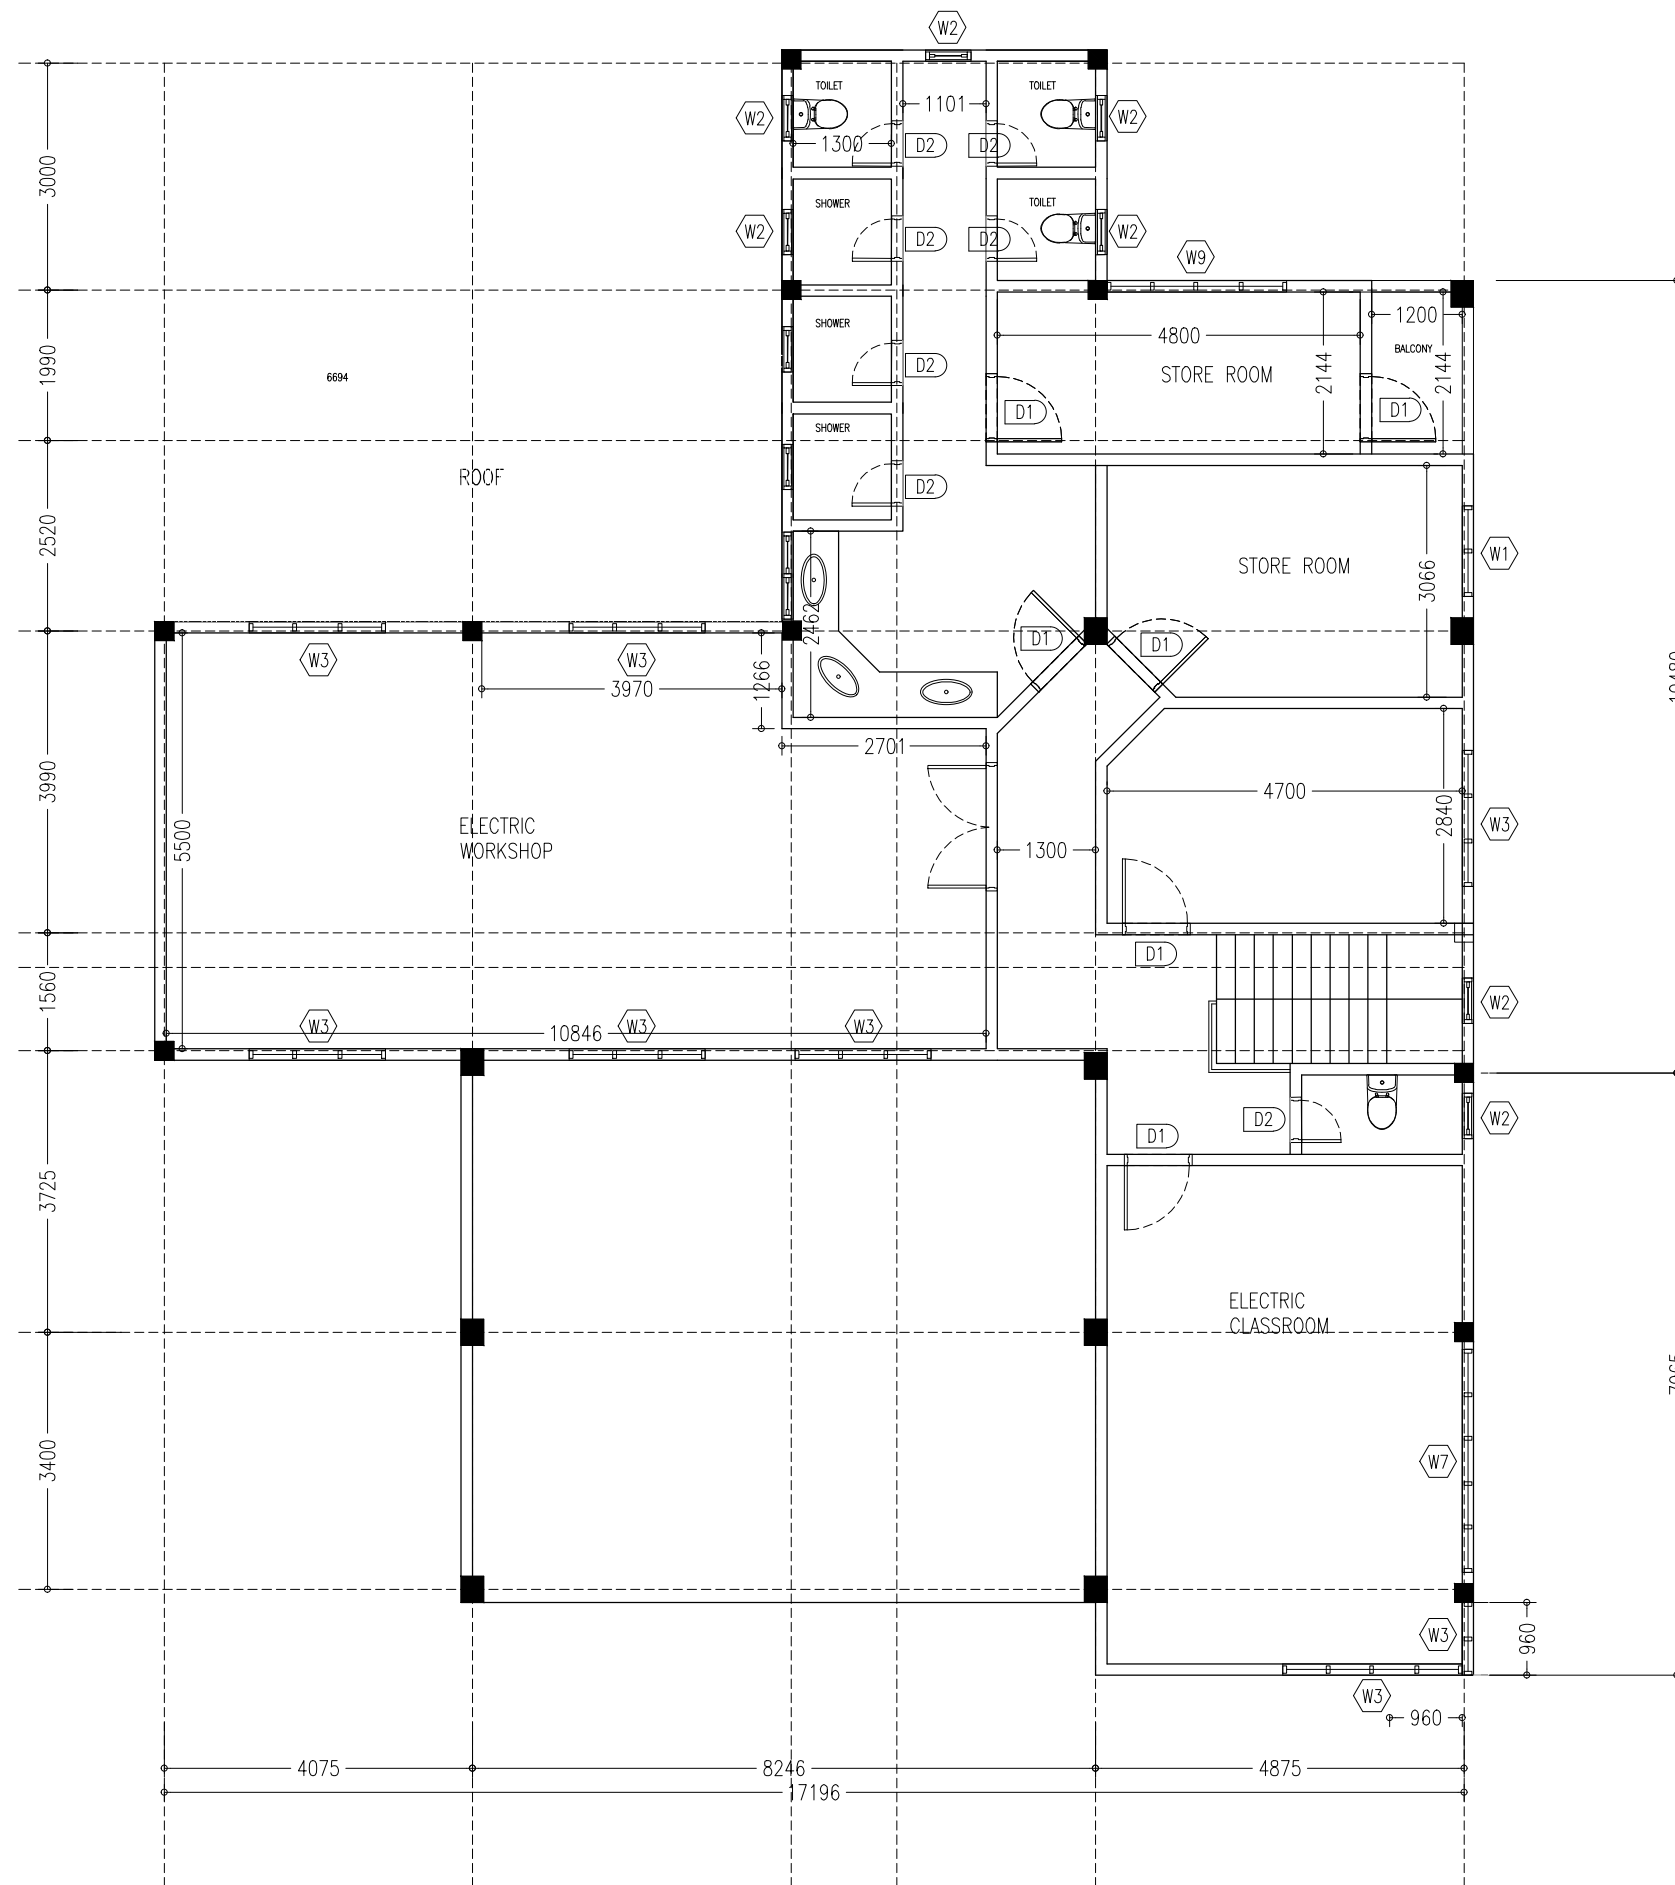

**FIRST FLOOR PLAN**  
SCALE 1:100

CONTRACTORS MUST CHECK ALL DIMENSIONS ON SITE BEFORE STARTING ANY WORK OR SHOP DRAWINGS. FIGURED DIMENSIONS TO TAKE PRECEDENCE OVER SCALE READINGS





REVISION:	ARCHITECT:	PROJECT:	MALDIVES POLYTECHNIC, SEENU. HITHADHOO CAMPUS
	ENGINEER:	LOCATION:	SEENU. HITHADHOO
	ARCHITECTURAL CHECKER:	DRAWING TITLE:	AS GIVEN
	STRUCTURAL CHECKER:	CLIENT:	MINISTRY OF HIGHER EDUCATION
	DRAWN BY: AISHATH HAMRA	SCALE: AS GIVEN	DIMENSION: MM
		DATE: SEPTMBER 2021	

**A-04**


DWG NO  
PROJECT NO: 21-001

CONCEPT AND DESIGN IN THIS DRAWING ARE THE PROPERTIES OF ARCHENG STUDIO PVT LTD. UNAUTHORIZED USE OR REPRODUCTION OF PART OF THE DESIGN, DRAWINGS OR CONCEPT TO USE IN OTHER PROJECTS OR SITES OTHER THAN SPECIFIED ON THIS DRAWING IS PROHIBITED

 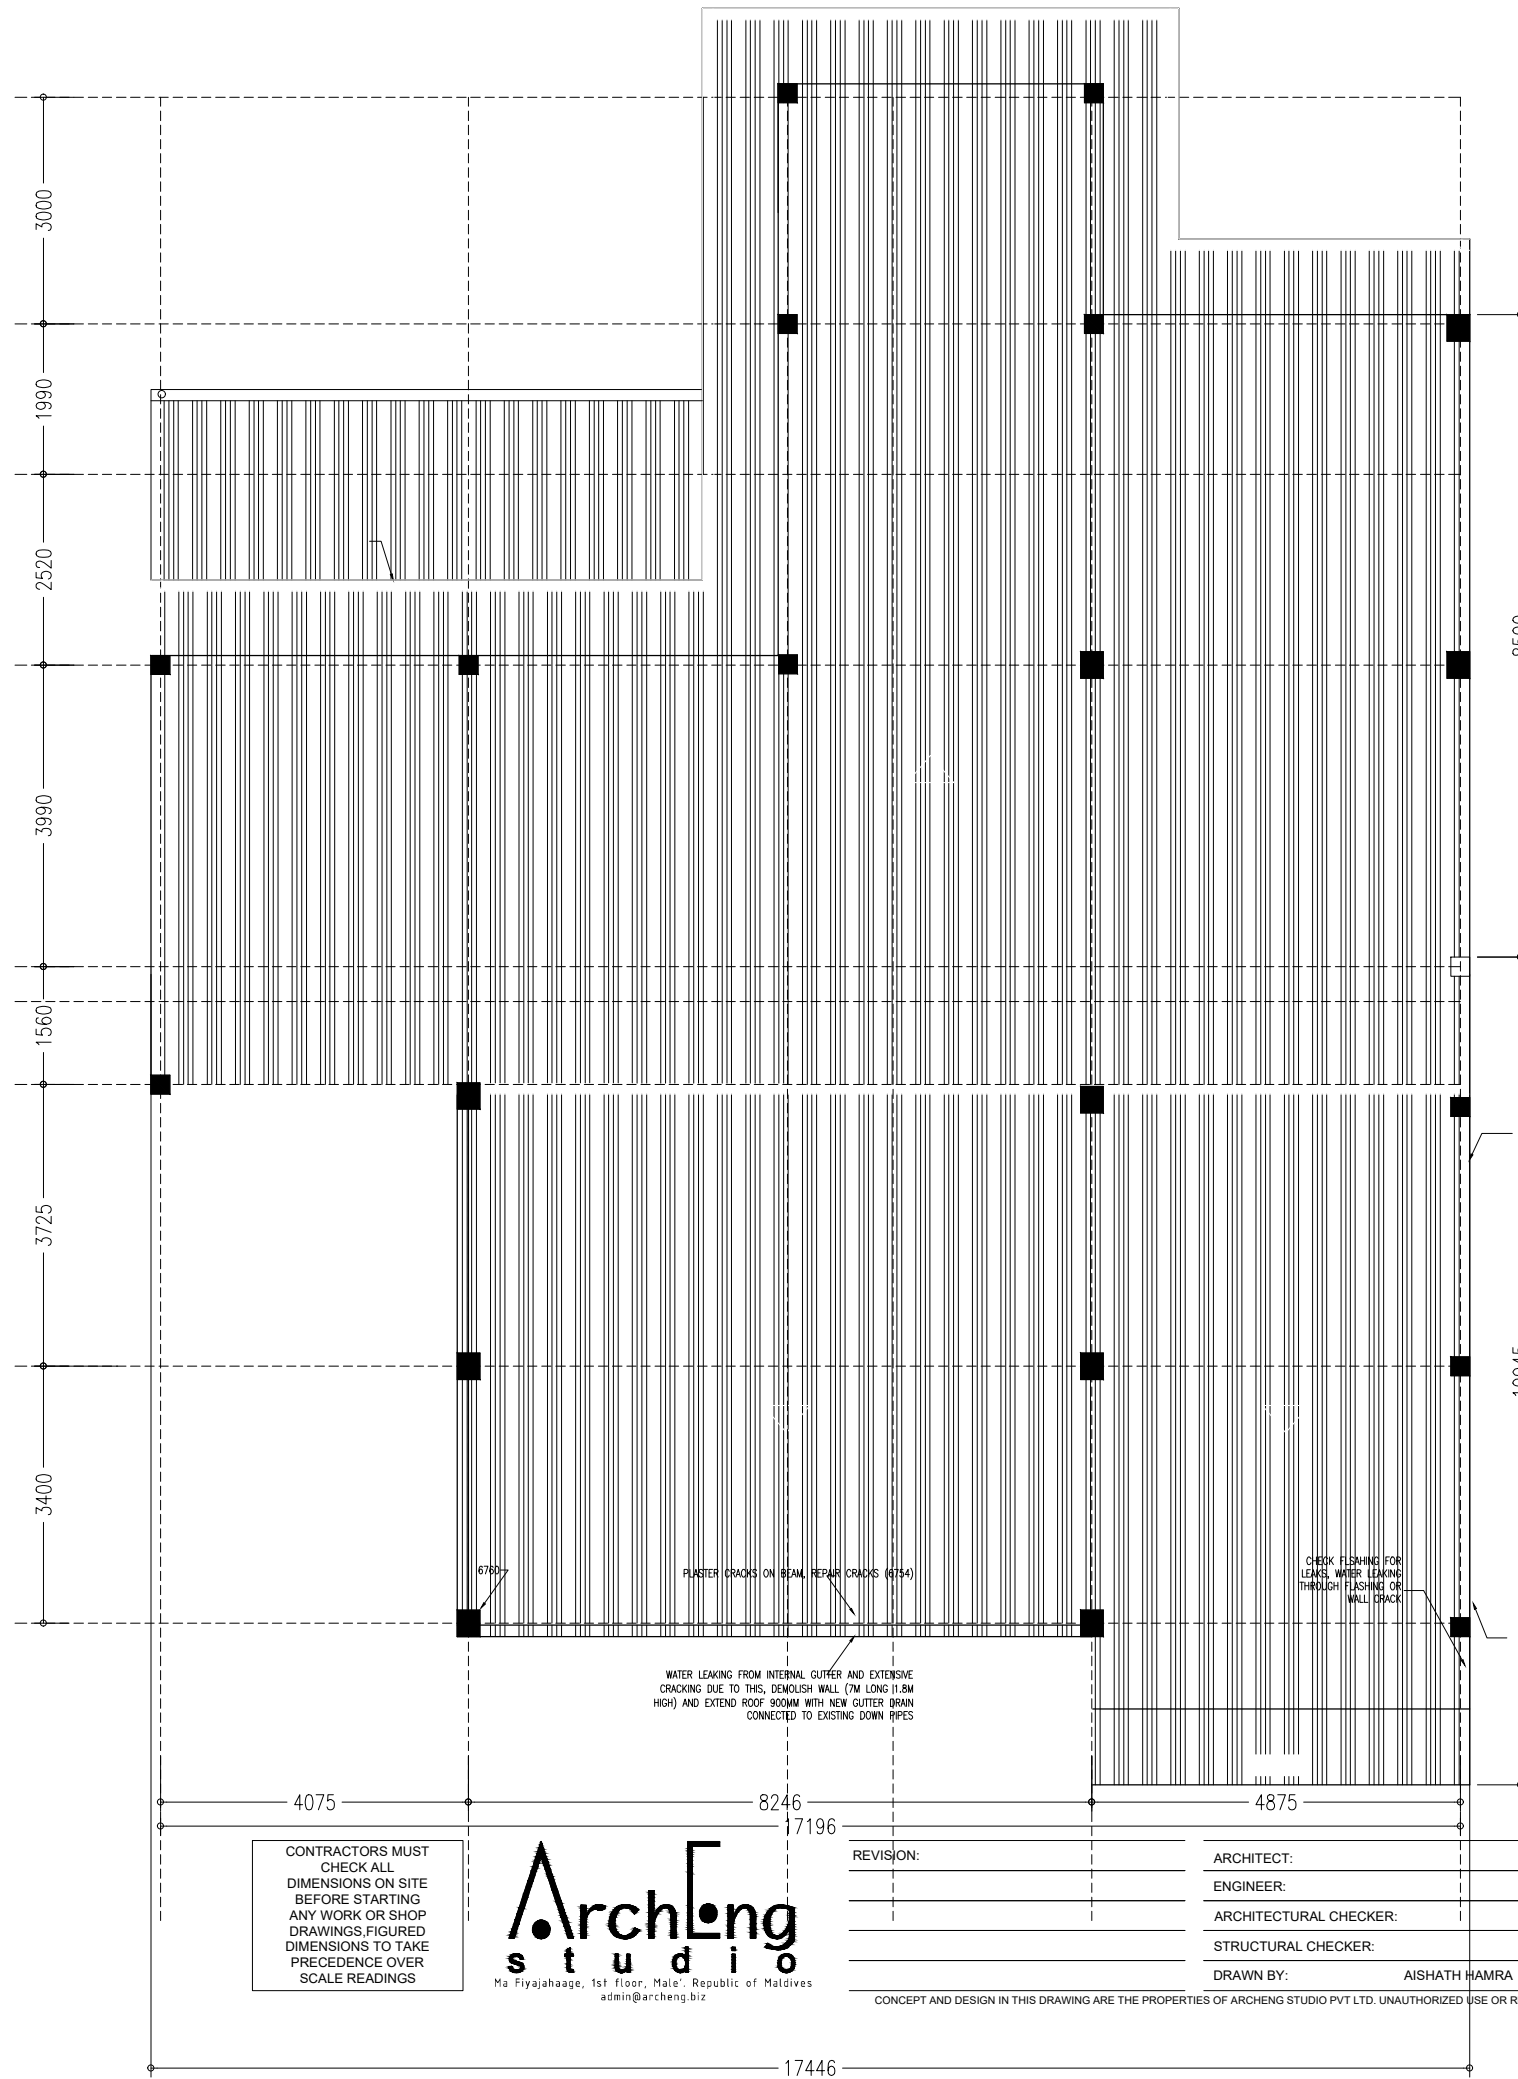

**ROOF PLAN**  
SCALE 1:100

CONTRACTORS MUST CHECK ALL DIMENSIONS ON SITE BEFORE STARTING ANY WORK OR SHOP DRAWINGS. FIGURED DIMENSIONS TO TAKE PRECEDENCE OVER SCALE READINGS

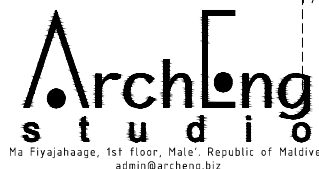


REVISION:	ARCHITECT:
	ENGINEER:
	ARCHITECTURAL CHECKER:
	STRUCTURAL CHECKER:
	DRAWN BY: AISHATH HAMRA

PROJECT:	MALDIVES POLYTECHNIC, SEENU. HITHADHOO CAMPUS
LOCATION:	SEENU. HITHADHOO
DRAWING TITLE:	AS GIVEN
CLIENT:	MINISTRY OF HIGHER EDUCATION
SCALE:	AS GIVEN
DIMENSION:	MM
DATE:	SEPTMBER 2021

DWG NO	<b>A-05</b>
PROJECT NO:	21-001

CONCEPT AND DESIGN IN THIS DRAWING ARE THE PROPERTIES OF ARCHENG STUDIO PVT LTD. UNAUTHORIZED USE OR REPRODUCTION OF PART OF THE DESIGN, DRAWINGS OR CONCEPT TO USE IN OTHER PROJECTS OR SITES OTHER THAN SPECIFIED ON THIS DRAWING IS PROHIBITED

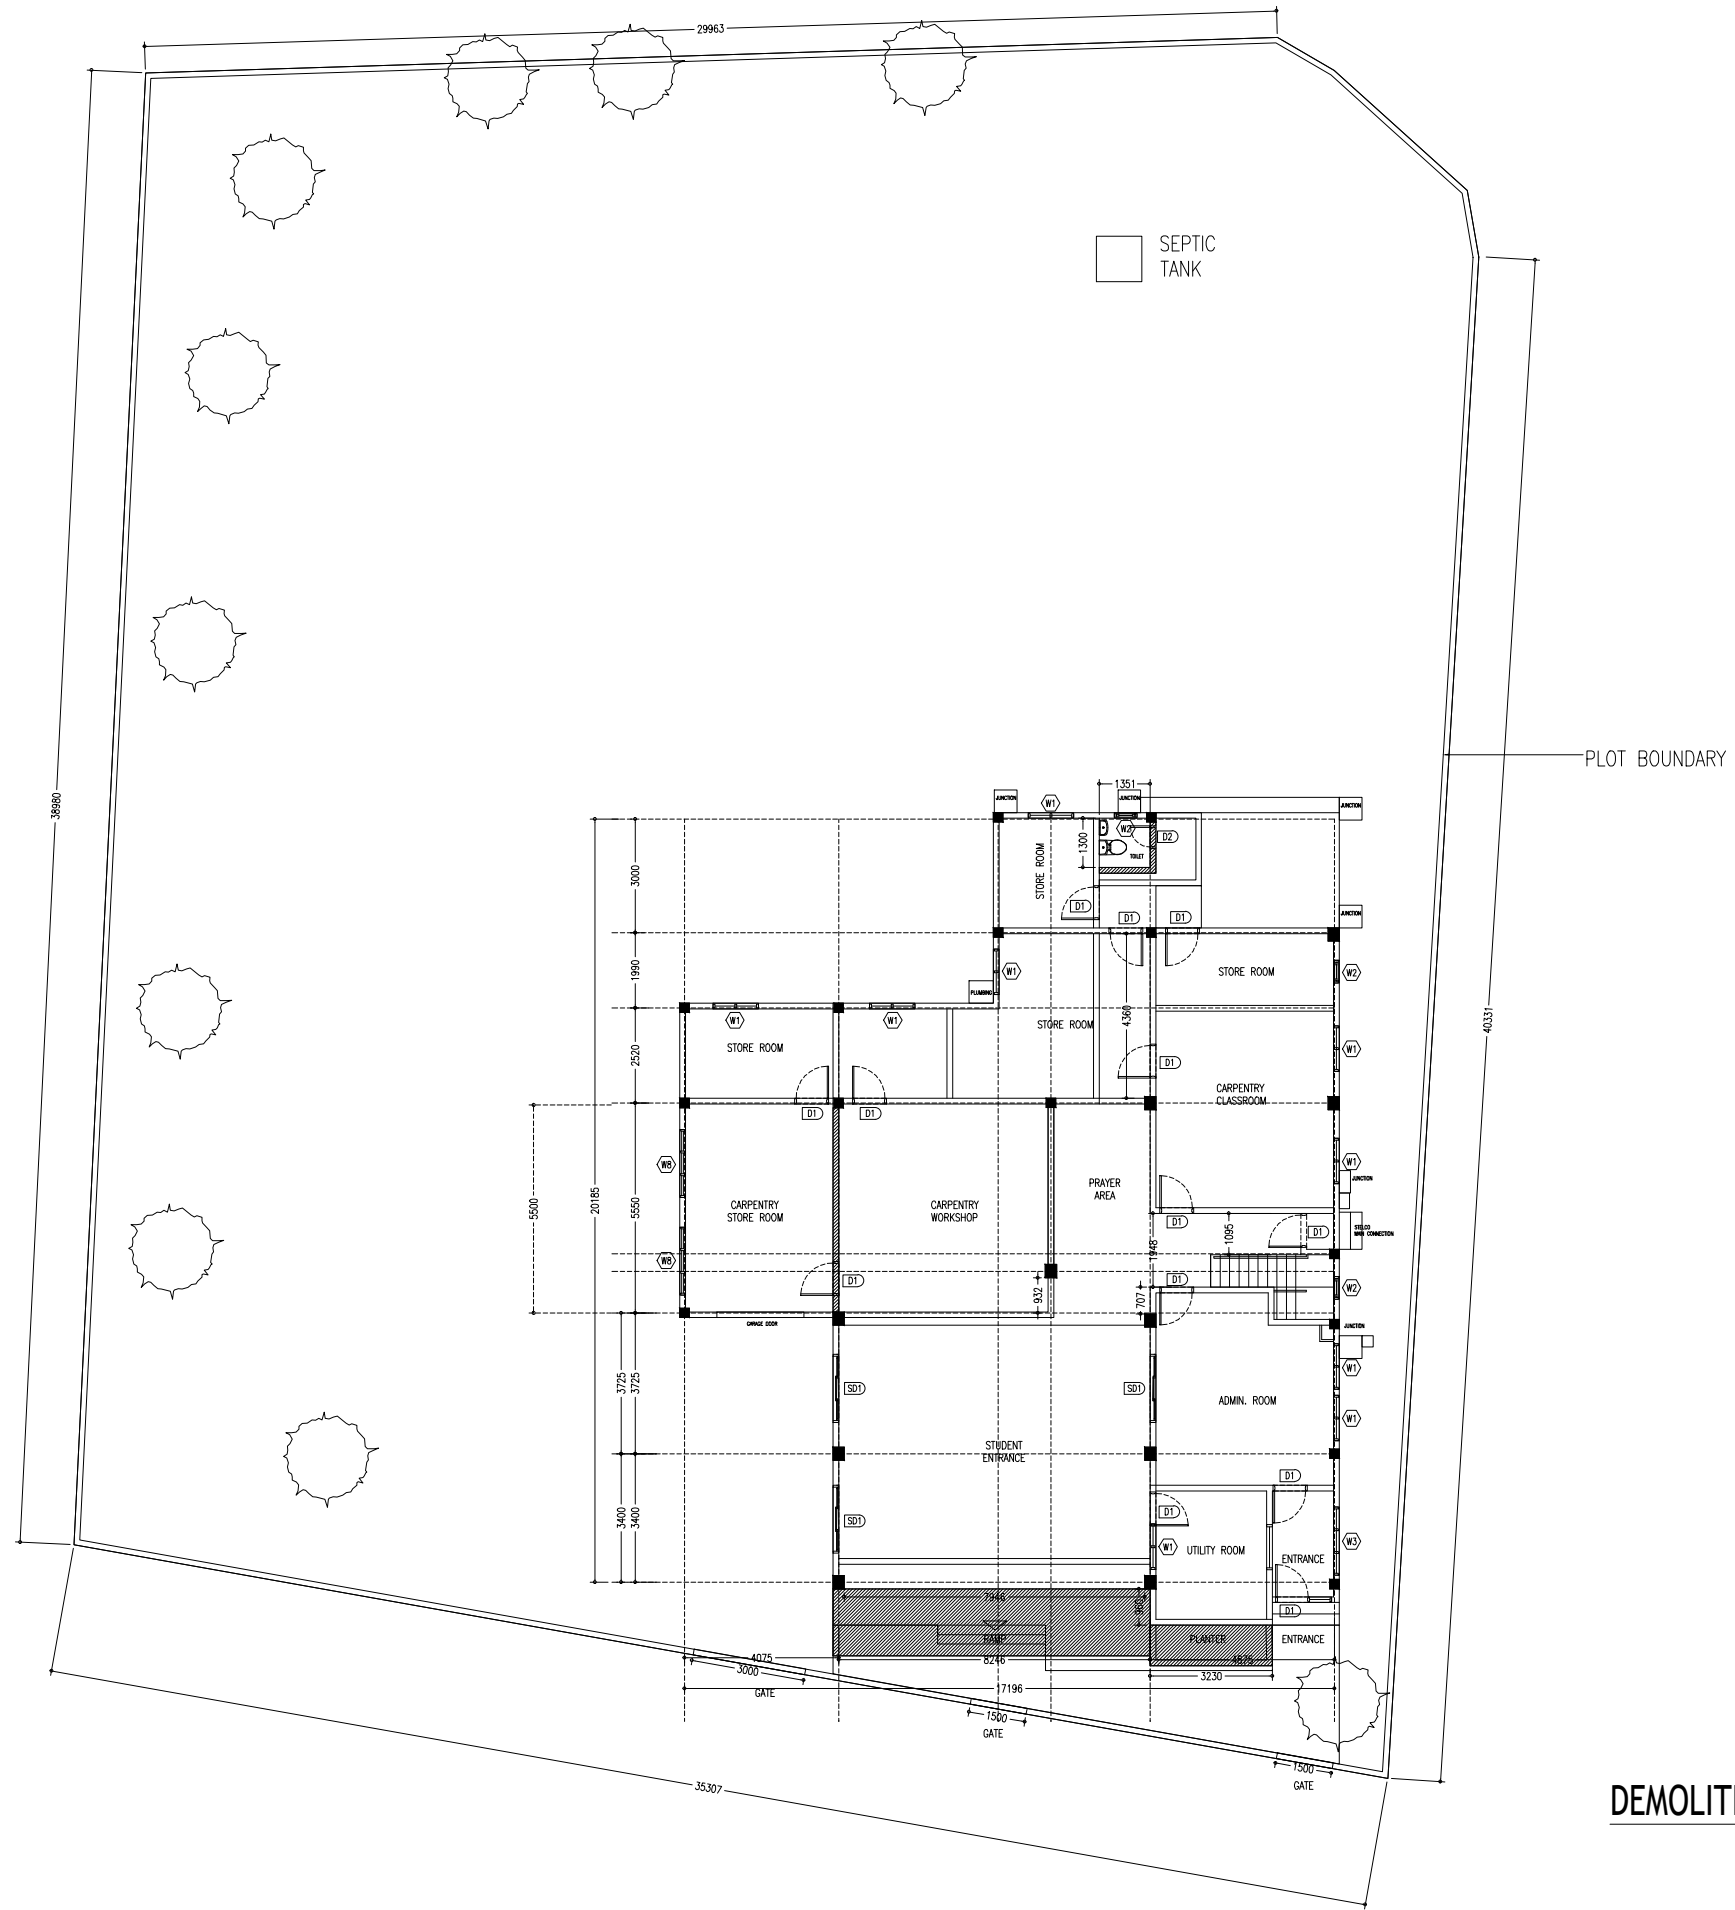

**DEMOLITION AND NEW WORK PLAN-SITE PLAN**

SCALE 1:200

CONTRACTORS MUST CHECK ALL DIMENSIONS ON SITE BEFORE STARTING ANY WORK OR SHOP DRAWINGS. FIGURED DIMENSIONS TO TAKE PRECEDENCE OVER SCALE READINGS



REVISION:	ARCHITECT:	PROJECT:	MALDIVES POLYTECHNIC, SEENU. HITHADHOO CAMPUS
	ENGINEER:	LOCATION:	SEENU. HITHADHOO
	ARCHITECTURAL CHECKER:	DRAWING TITLE:	AS GIVEN
	STRUCTURAL CHECKER:	CLIENT:	MINISTRY OF HIGHER EDUCATION
	DRAWN BY: AISHATH HAMRA	SCALE: AS GIVEN	DIMENSION: MM
		DATE: SEPTMBER 2021	


**A-06**

DWG NO  
PROJECT NO: 21-001

CONCEPT AND DESIGN IN THIS DRAWING ARE THE PROPERTIES OF ARCHENG STUDIO PVT LTD. UNAUTHORIZED USE OR REPRODUCTION OF PART OF THE DESIGN, DRAWINGS OR CONCEPT TO USE IN OTHER PROJECTS OR SITES OTHER THAN SPECIFIED ON THIS DRAWING IS PROHIBITED





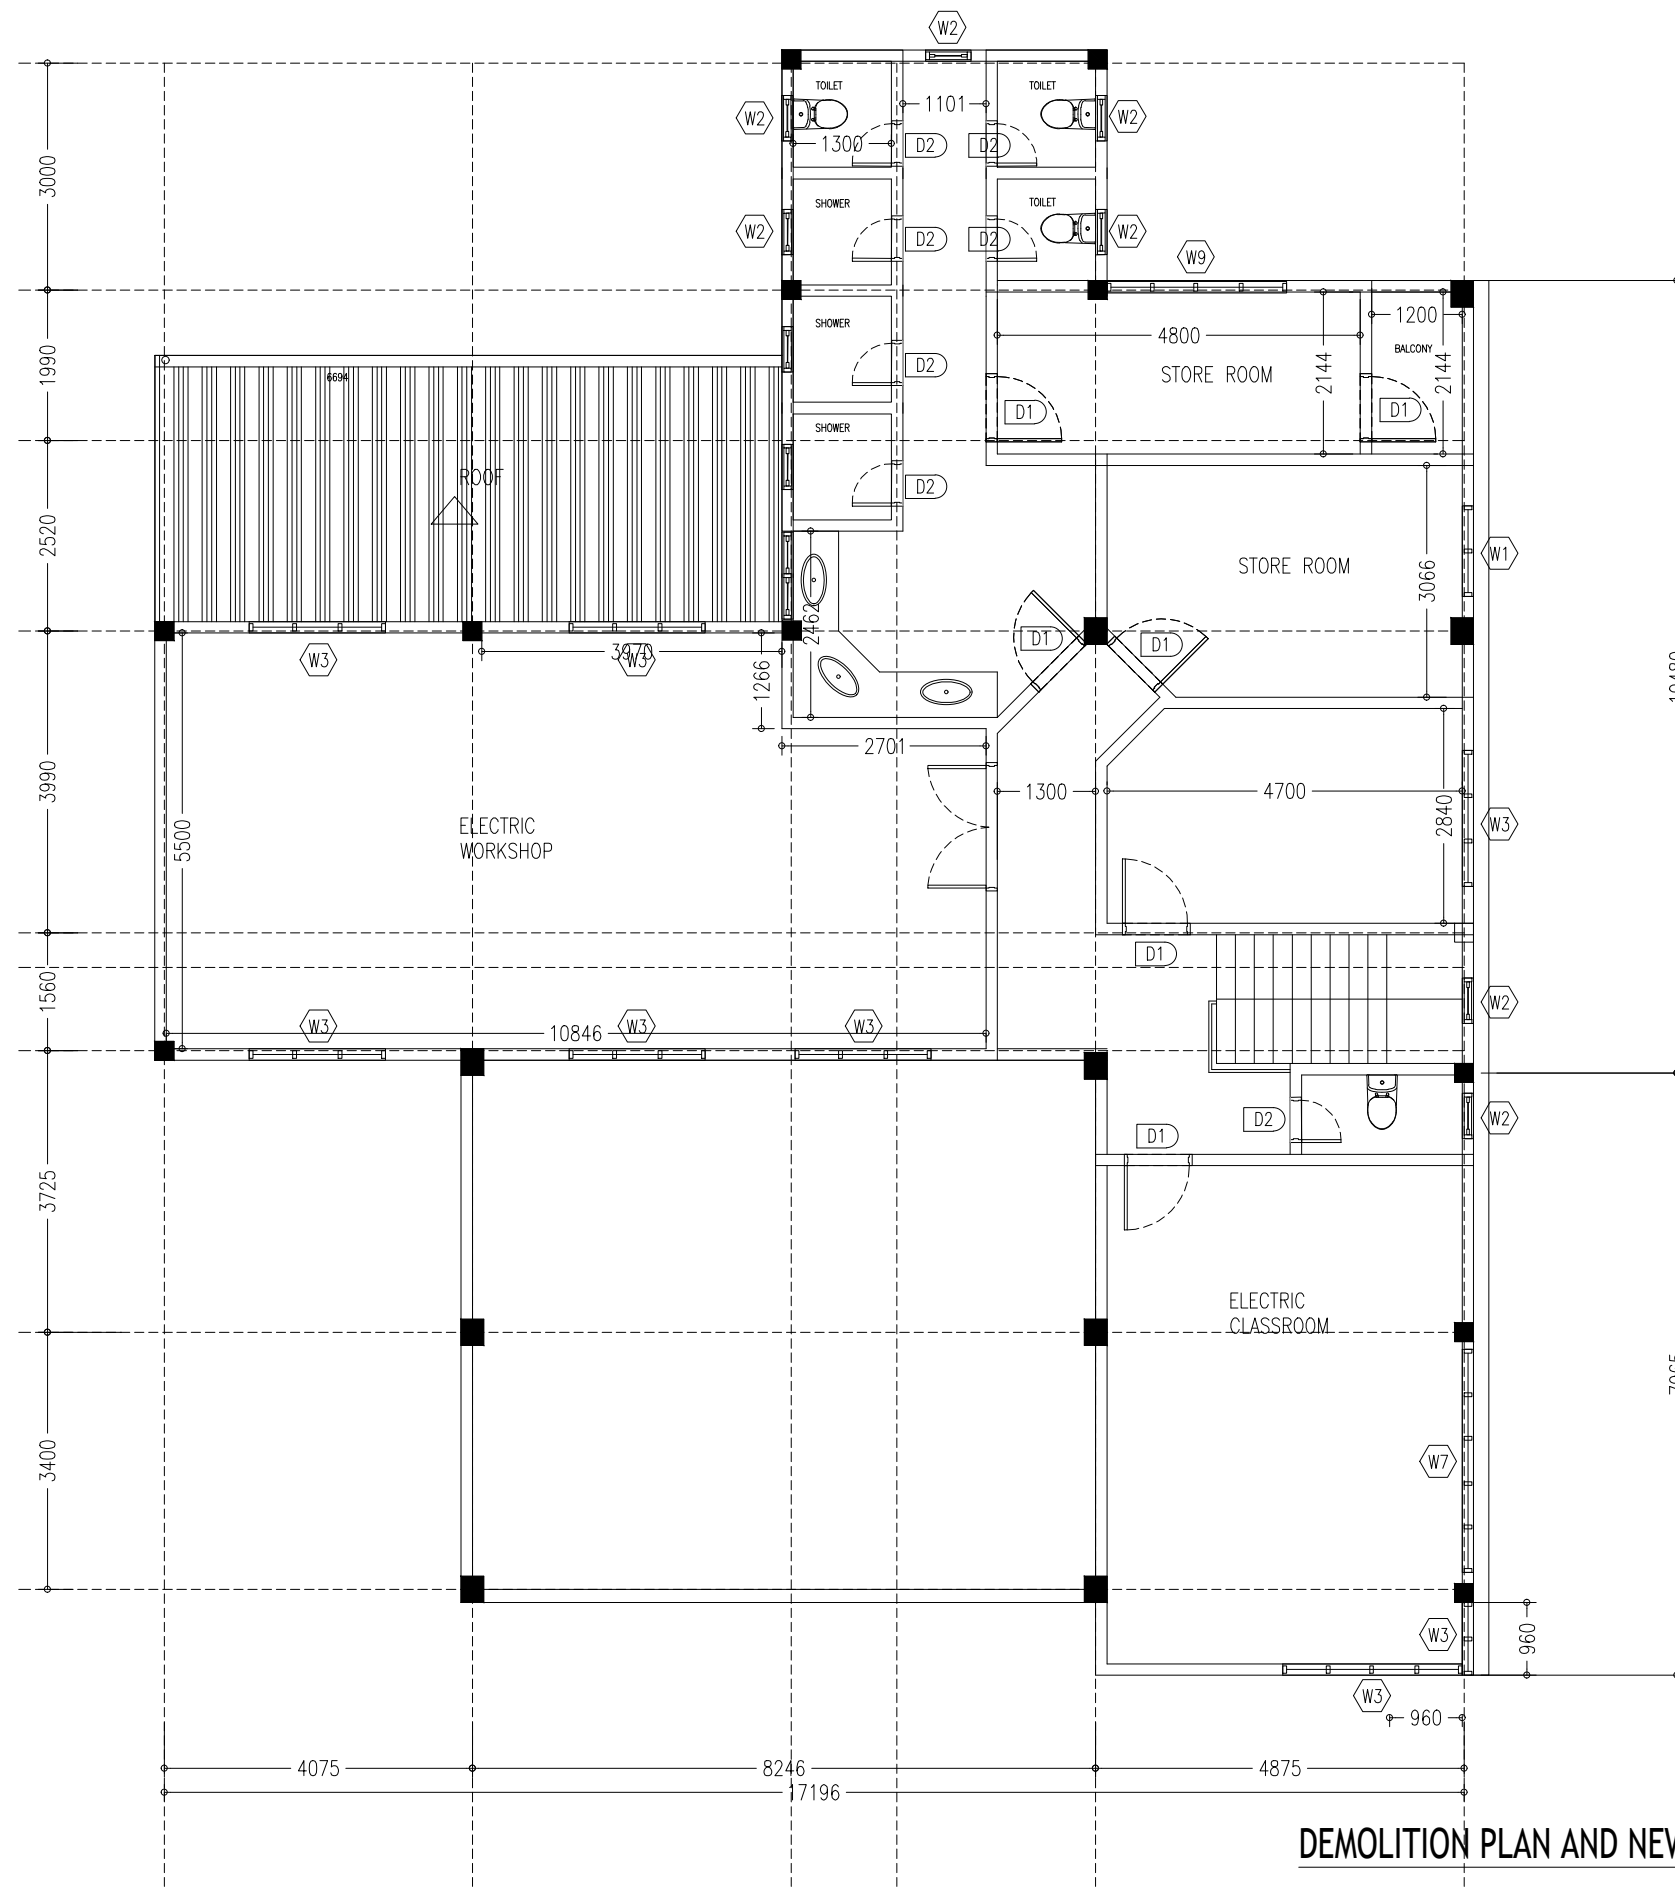

**DEMOLITION PLAN AND NEW WORK PLAN - FIRST FLOOR**  
SCALE 1:100

CONTRACTORS MUST CHECK ALL DIMENSIONS ON SITE BEFORE STARTING ANY WORK OR SHOP DRAWINGS. FIGURED DIMENSIONS TO TAKE PRECEDENCE OVER SCALE READINGS






REVISION:

ARCHITECT:  
ENGINEER:  
ARCHITECTURAL CHECKER:  
STRUCTURAL CHECKER:  
DRAWN BY: AISHATH HAMRA

PROJECT: MALDIVES POLYTECHNIC, SEENU. HITHADHOO CAMPUS  
LOCATION: SEENU. HITHADHOO  
DRAWING TITLE: AS GIVEN  
CLIENT: MINISTRY OF HIGHER EDUCATION  
SCALE: AS GIVEN DIMENSION: MM DATE: SEPTMBER 2021

**A-08**

  DWG NO  
PROJECT NO: 21-001

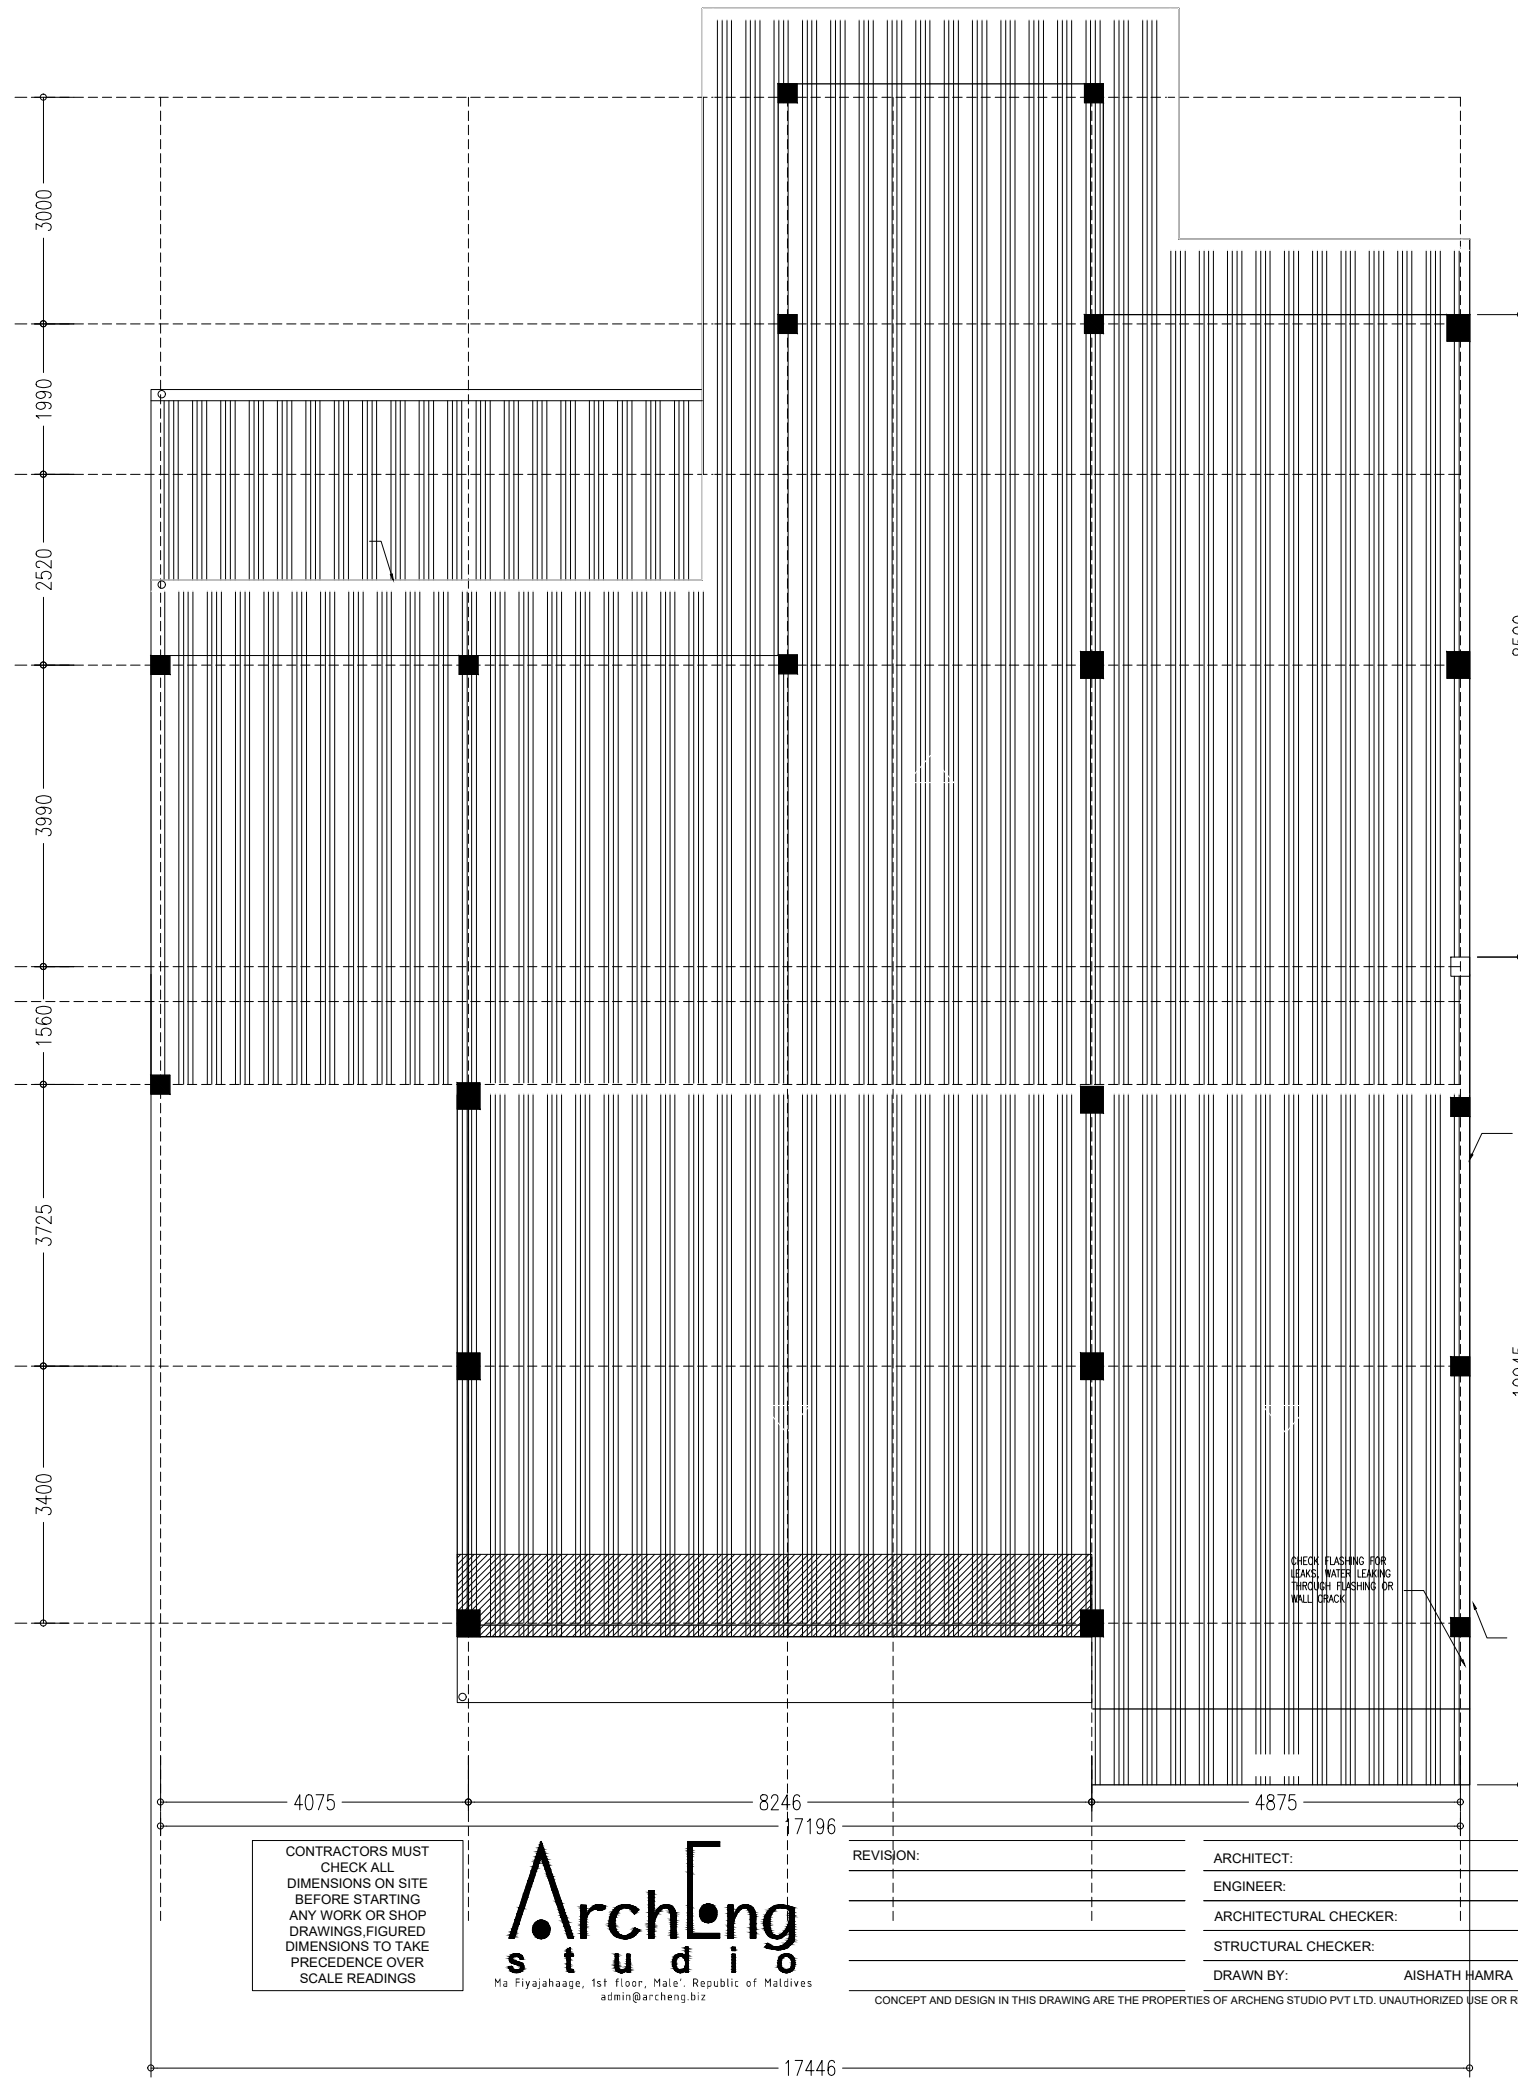

**DEMOLITION AND NEW WORK PLAN -ROOF**  
SCALE 1:200

CONTRACTORS MUST CHECK ALL DIMENSIONS ON SITE BEFORE STARTING ANY WORK OR SHOP DRAWINGS. FIGURED DIMENSIONS TO TAKE PRECEDENCE OVER SCALE READINGS




REVISION:	ARCHITECT:
	ENGINEER:
	ARCHITECTURAL CHECKER:
	STRUCTURAL CHECKER:
	DRAWN BY: AISHATH HAMRA

PROJECT:	MALDIVES POLYTECHNIC, SEENU. HITHADHOO CAMPUS
LOCATION:	SEENU. HITHADHOO
DRAWING TITLE:	AS GIVEN
CLIENT:	MINISTRY OF HIGHER EDUCATION
SCALE: AS GIVEN	DIMENSION: MM
DATE: SEPTMBER 2021	

**A-09**  
DWG NO  
PROJECT NO: 21-001

CONCEPT AND DESIGN IN THIS DRAWING ARE THE PROPERTIES OF ARCHENG STUDIO PVT LTD. UNAUTHORIZED USE OR REPRODUCTION OF PART OF THE DESIGN, DRAWINGS OR CONCEPT TO USE IN OTHER PROJECTS OR SITES OTHER THAN SPECIFIED ON THIS DRAWING IS PROHIBITED

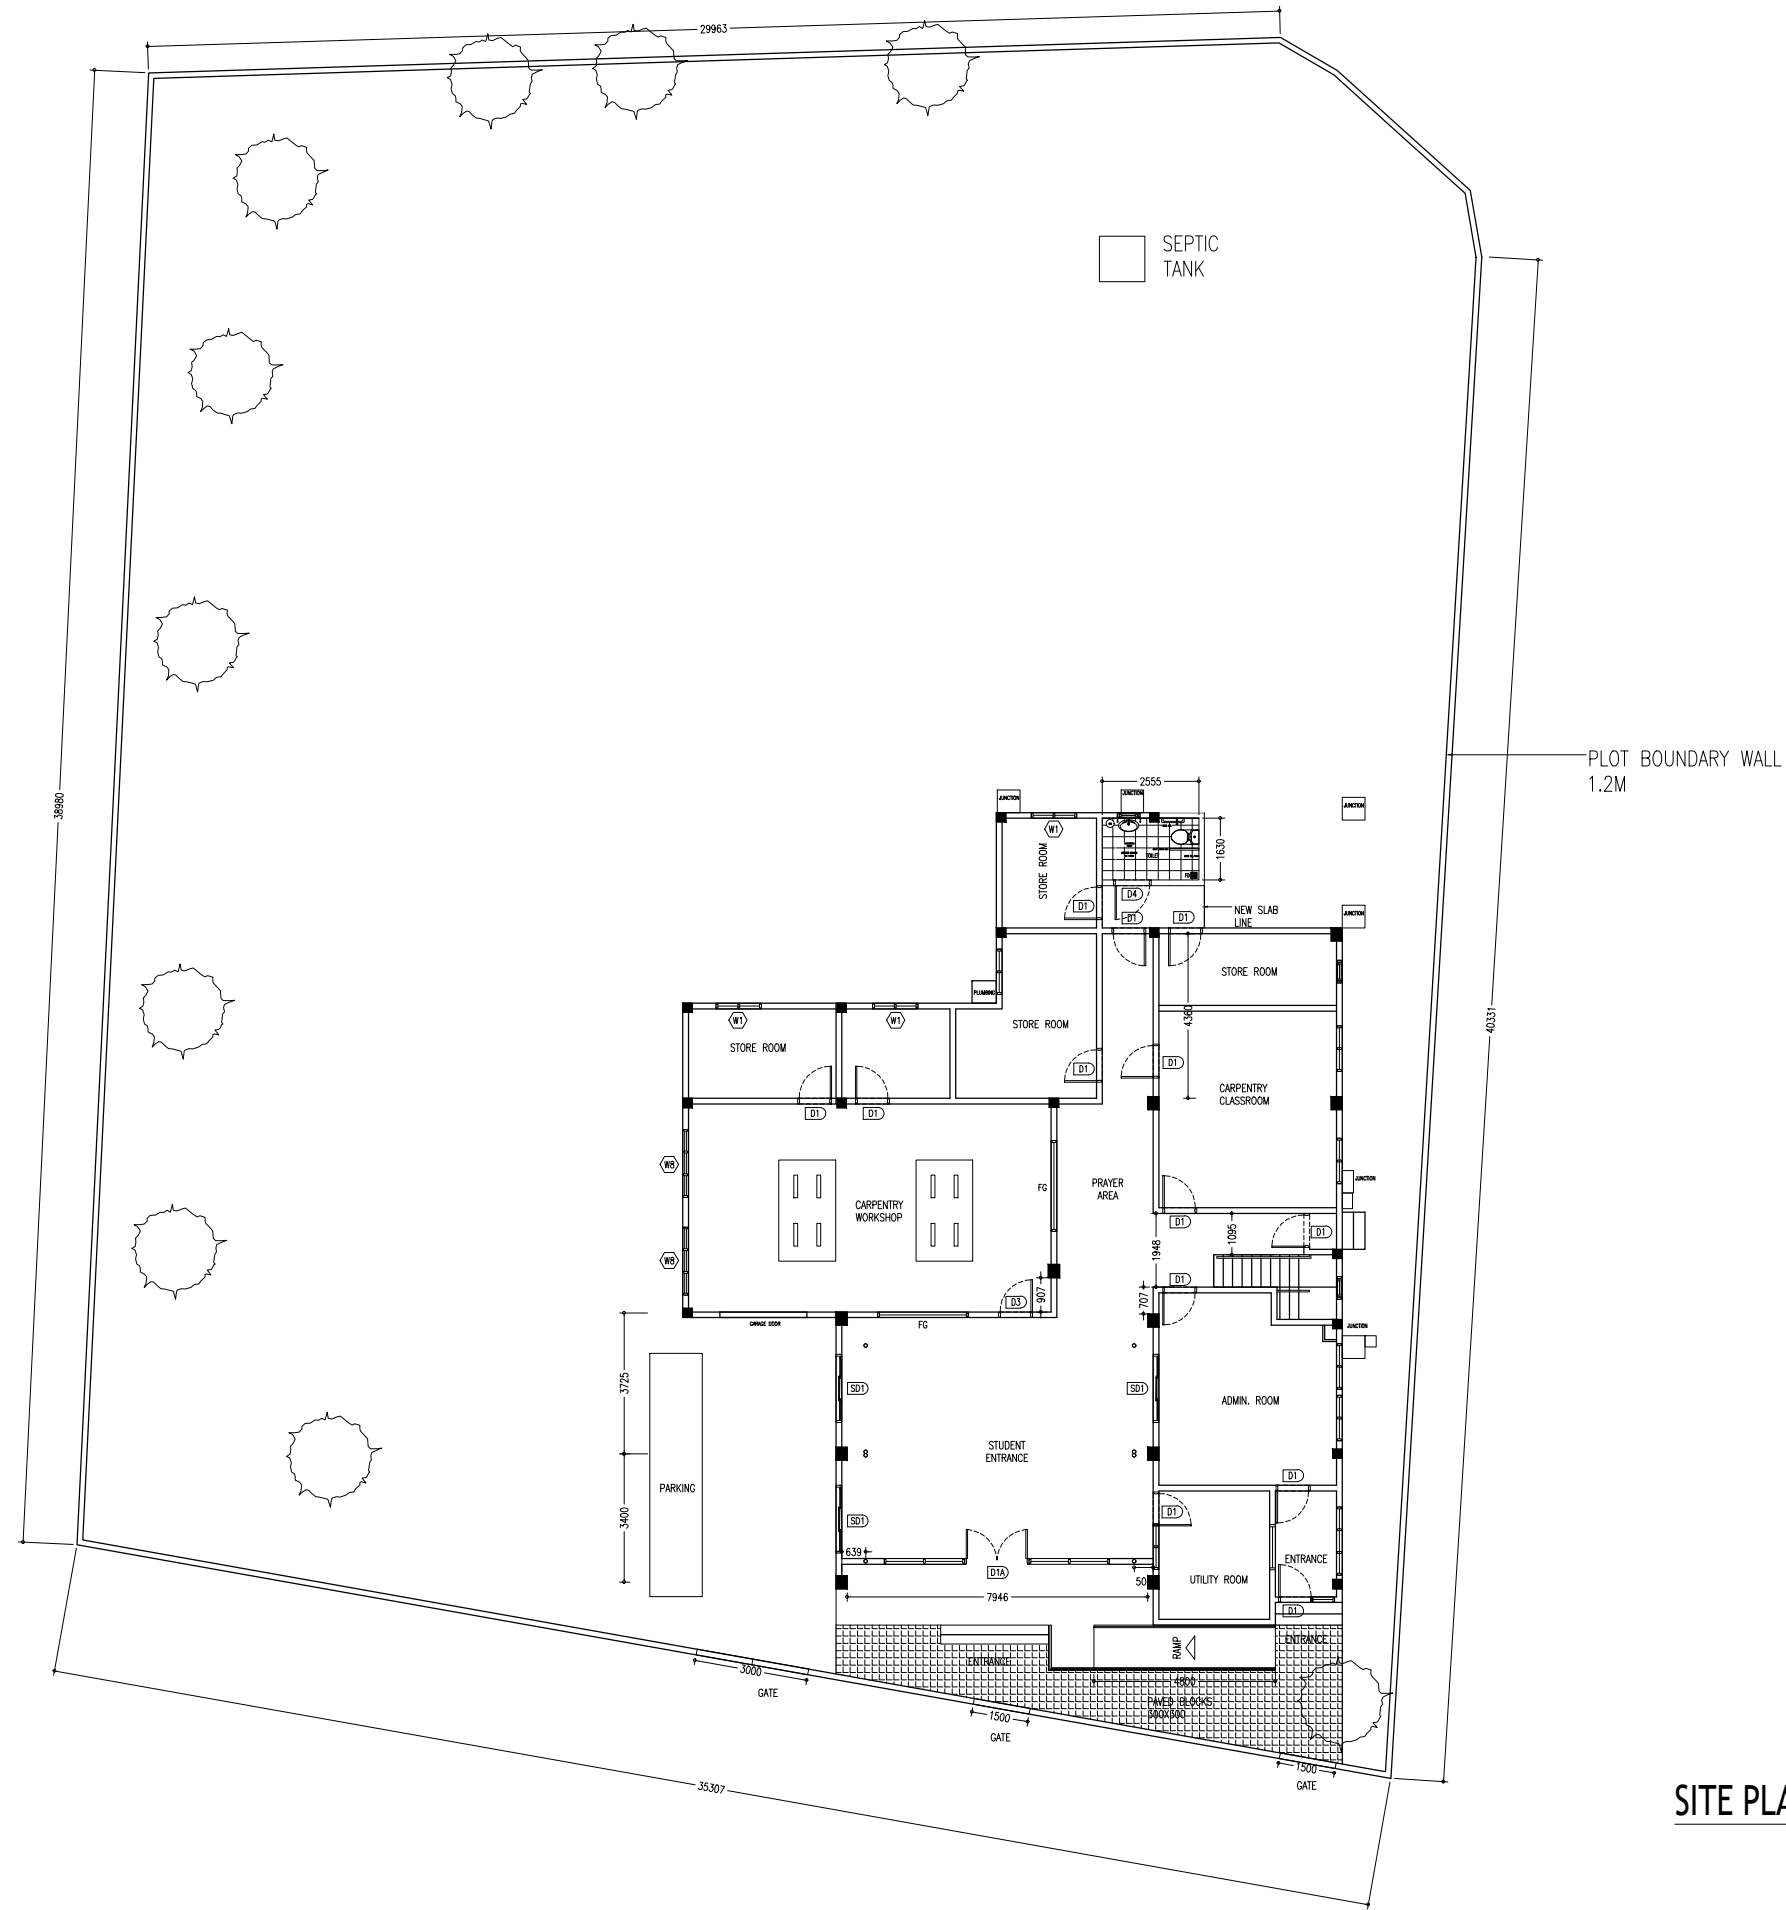

**SITE PLAN - PROPOSED PLAN**  
SCALE 1:200

CONTRACTORS MUST CHECK ALL DIMENSIONS ON SITE BEFORE STARTING ANY WORK OR SHOP DRAWINGS. FIGURED DIMENSIONS TO TAKE PRECEDENCE OVER SCALE READINGS




REVISION:	ARCHITECT:
	ENGINEER:
	ARCHITECTURAL CHECKER:
	STRUCTURAL CHECKER:
	DRAWN BY: AISHATH HAMRA

PROJECT: MALDIVES POLYTECHNIC, SEENU. HITHADHOO CAMPUS
LOCATION: SEENU. HITHADHOO
DRAWING TITLE: AS GIVEN
CLIENT: MINISTRY OF HIGHER EDUCATION
SCALE: AS GIVEN    DIMENSION: MM    DATE: SEPTMBER 2021

DWG NO
PROJECT NO: 21-001

**A-10**

CONCEPT AND DESIGN IN THIS DRAWING ARE THE PROPERTIES OF ARCHENG STUDIO PVT LTD. UNAUTHORIZED USE OR REPRODUCTION OF PART OF THE DESIGN, DRAWINGS OR CONCEPT TO USE IN OTHER PROJECTS OR SITES OTHER THAN SPECIFIED ON THIS DRAWING IS PROHIBITED

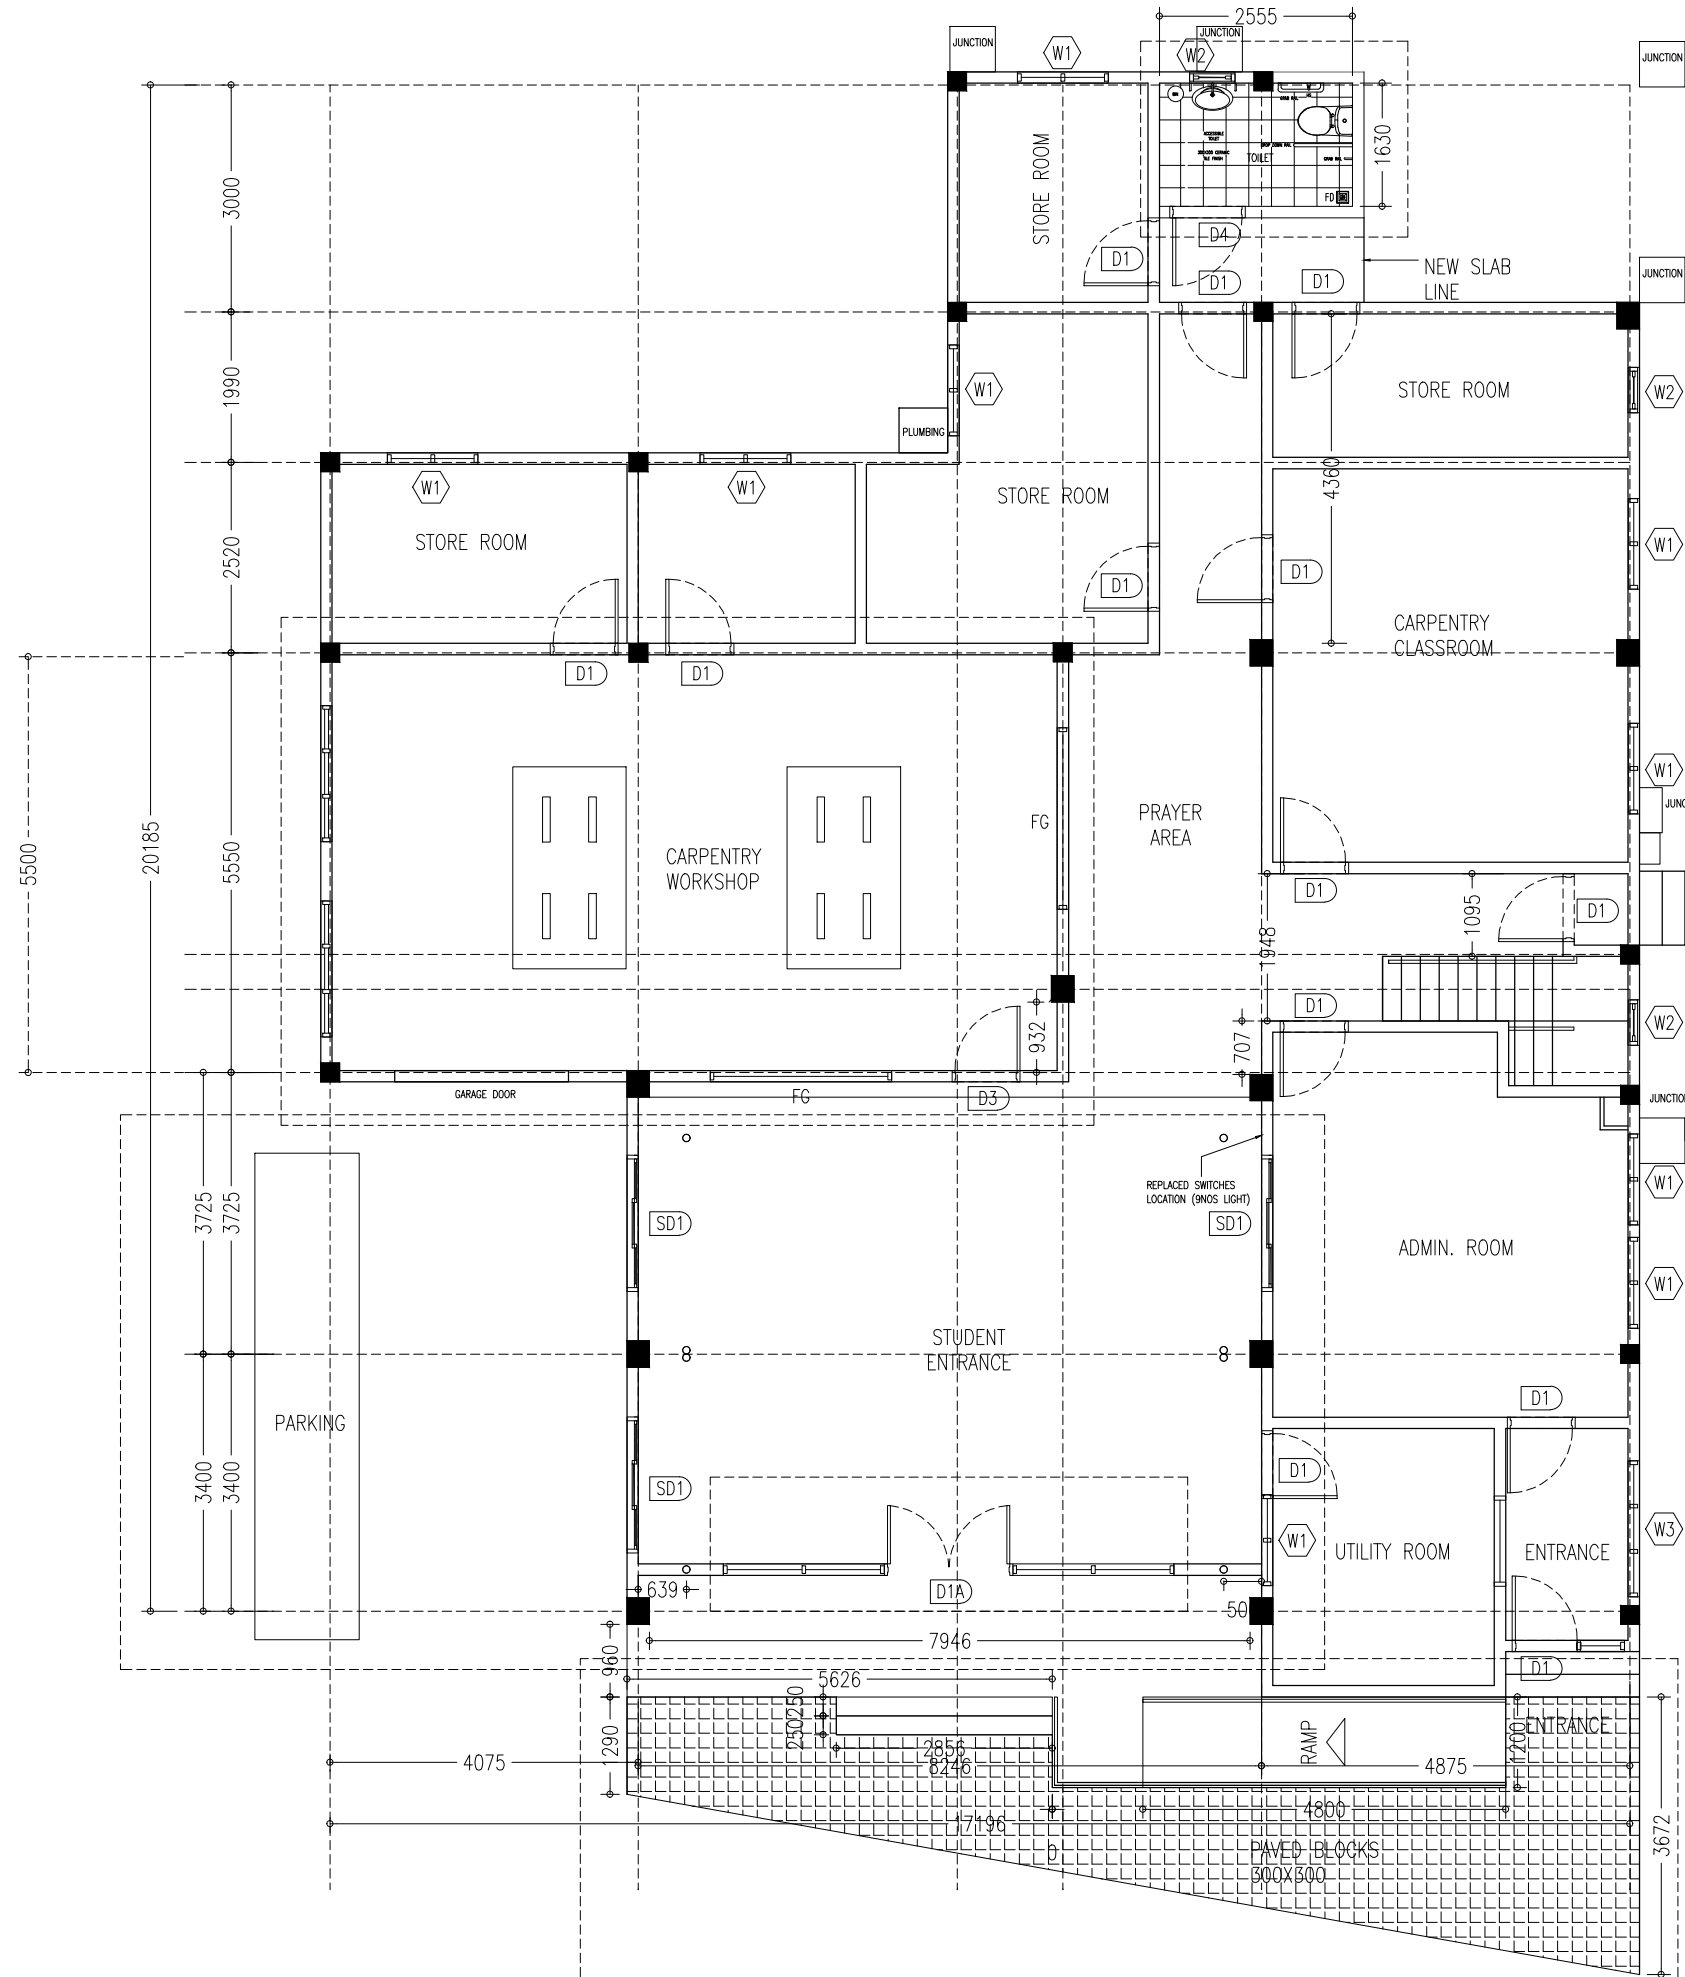

**GROUND FLOOR PLAN - PROPOSED PLAN**  
SCALE 1:100

CONTRACTORS MUST CHECK ALL DIMENSIONS ON SITE BEFORE STARTING ANY WORK OR SHOP DRAWINGS. FIGURED DIMENSIONS TO TAKE PRECEDENCE OVER SCALE READINGS




REVISION:	ARCHITECT:
	ENGINEER:
	ARCHITECTURAL CHECKER:
	STRUCTURAL CHECKER:
	DRAWN BY: AISHATH HAMRA

PROJECT:	MALDIVES POLYTECHNIC, SEENU. HITHADHOO CAMPUS
LOCATION:	SEENU. HITHADHOO
DRAWING TITLE:	AS GIVEN
CLIENT:	MINISTRY OF HIGHER EDUCATION
SCALE:	AS GIVEN
DIMENSION:	MM
DATE:	SEPTEMBER 2021

DWG NO	A-11
PROJECT NO:	21-001

CONCEPT AND DESIGN IN THIS DRAWING ARE THE PROPERTIES OF ARCHENG STUDIO PVT LTD. UNAUTHORIZED USE OR REPRODUCTION OF PART OF THE DESIGN, DRAWINGS OR CONCEPT TO USE IN OTHER PROJECTS OR SITES OTHER THAN SPECIFIED ON THIS DRAWING IS PROHIBITED

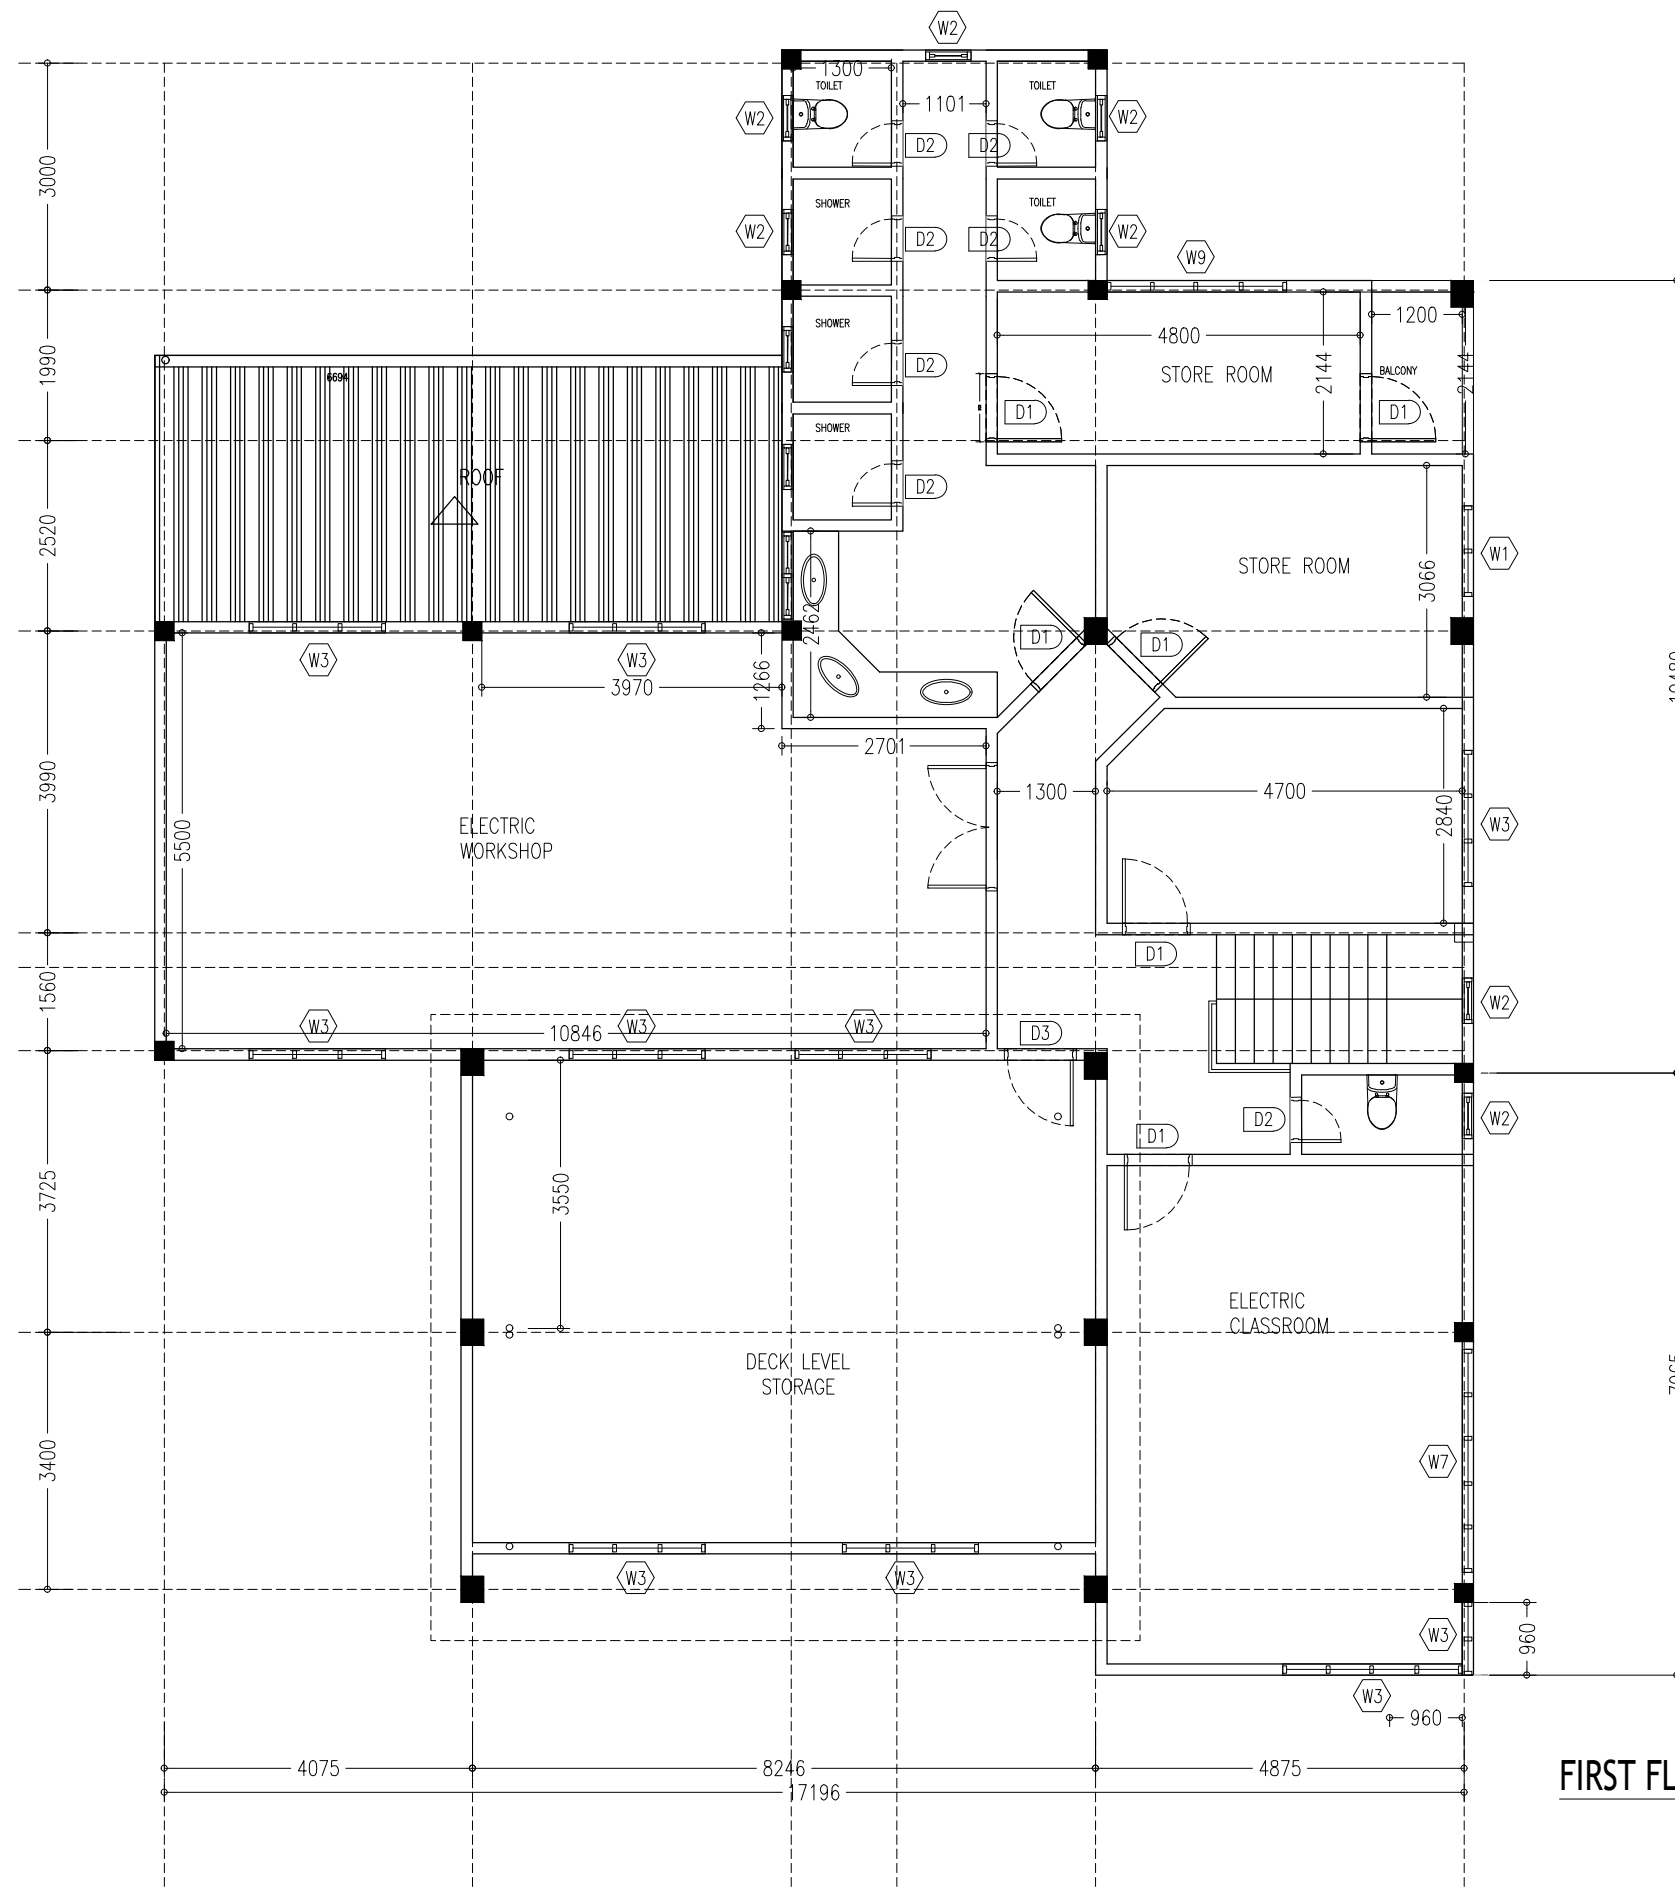

**FIRST FLOOR PLAN - PROPOSED PLAN**  
SCALE 1:100

CONTRACTORS MUST CHECK ALL DIMENSIONS ON SITE BEFORE STARTING ANY WORK OR SHOP DRAWINGS. FIGURED DIMENSIONS TO TAKE PRECEDENCE OVER SCALE READINGS




REVISION:	ARCHITECT:	PROJECT:
	ENGINEER:	LOCATION:
	ARCHITECTURAL CHECKER:	DRAWING TITLE:
	STRUCTURAL CHECKER:	CLIENT:
	DRAWN BY: AISHATH HAMRA	SCALE: AS GIVEN
		DIMENSION: MM
		DATE: SEPTMBER 2021

PROJECT:	MALDIVES POLYTECHNIC, SEENU. HITHADHOO CAMPUS
LOCATION:	SEENU. HITHADHOO
DRAWING TITLE:	AS GIVEN
CLIENT:	MINISTRY OF HIGHER EDUCATION
SCALE:	AS GIVEN
DIMENSION:	MM
DATE:	SEPTMBER 2021

<b>A-12</b>
DWG NO
PROJECT NO: 21-001

CONCEPT AND DESIGN IN THIS DRAWING ARE THE PROPERTIES OF ARCHENG STUDIO PVT LTD. UNAUTHORIZED USE OR REPRODUCTION OF PART OF THE DESIGN, DRAWINGS OR CONCEPT TO USE IN OTHER PROJECTS OR SITES OTHER THAN SPECIFIED ON THIS DRAWING IS PROHIBITED

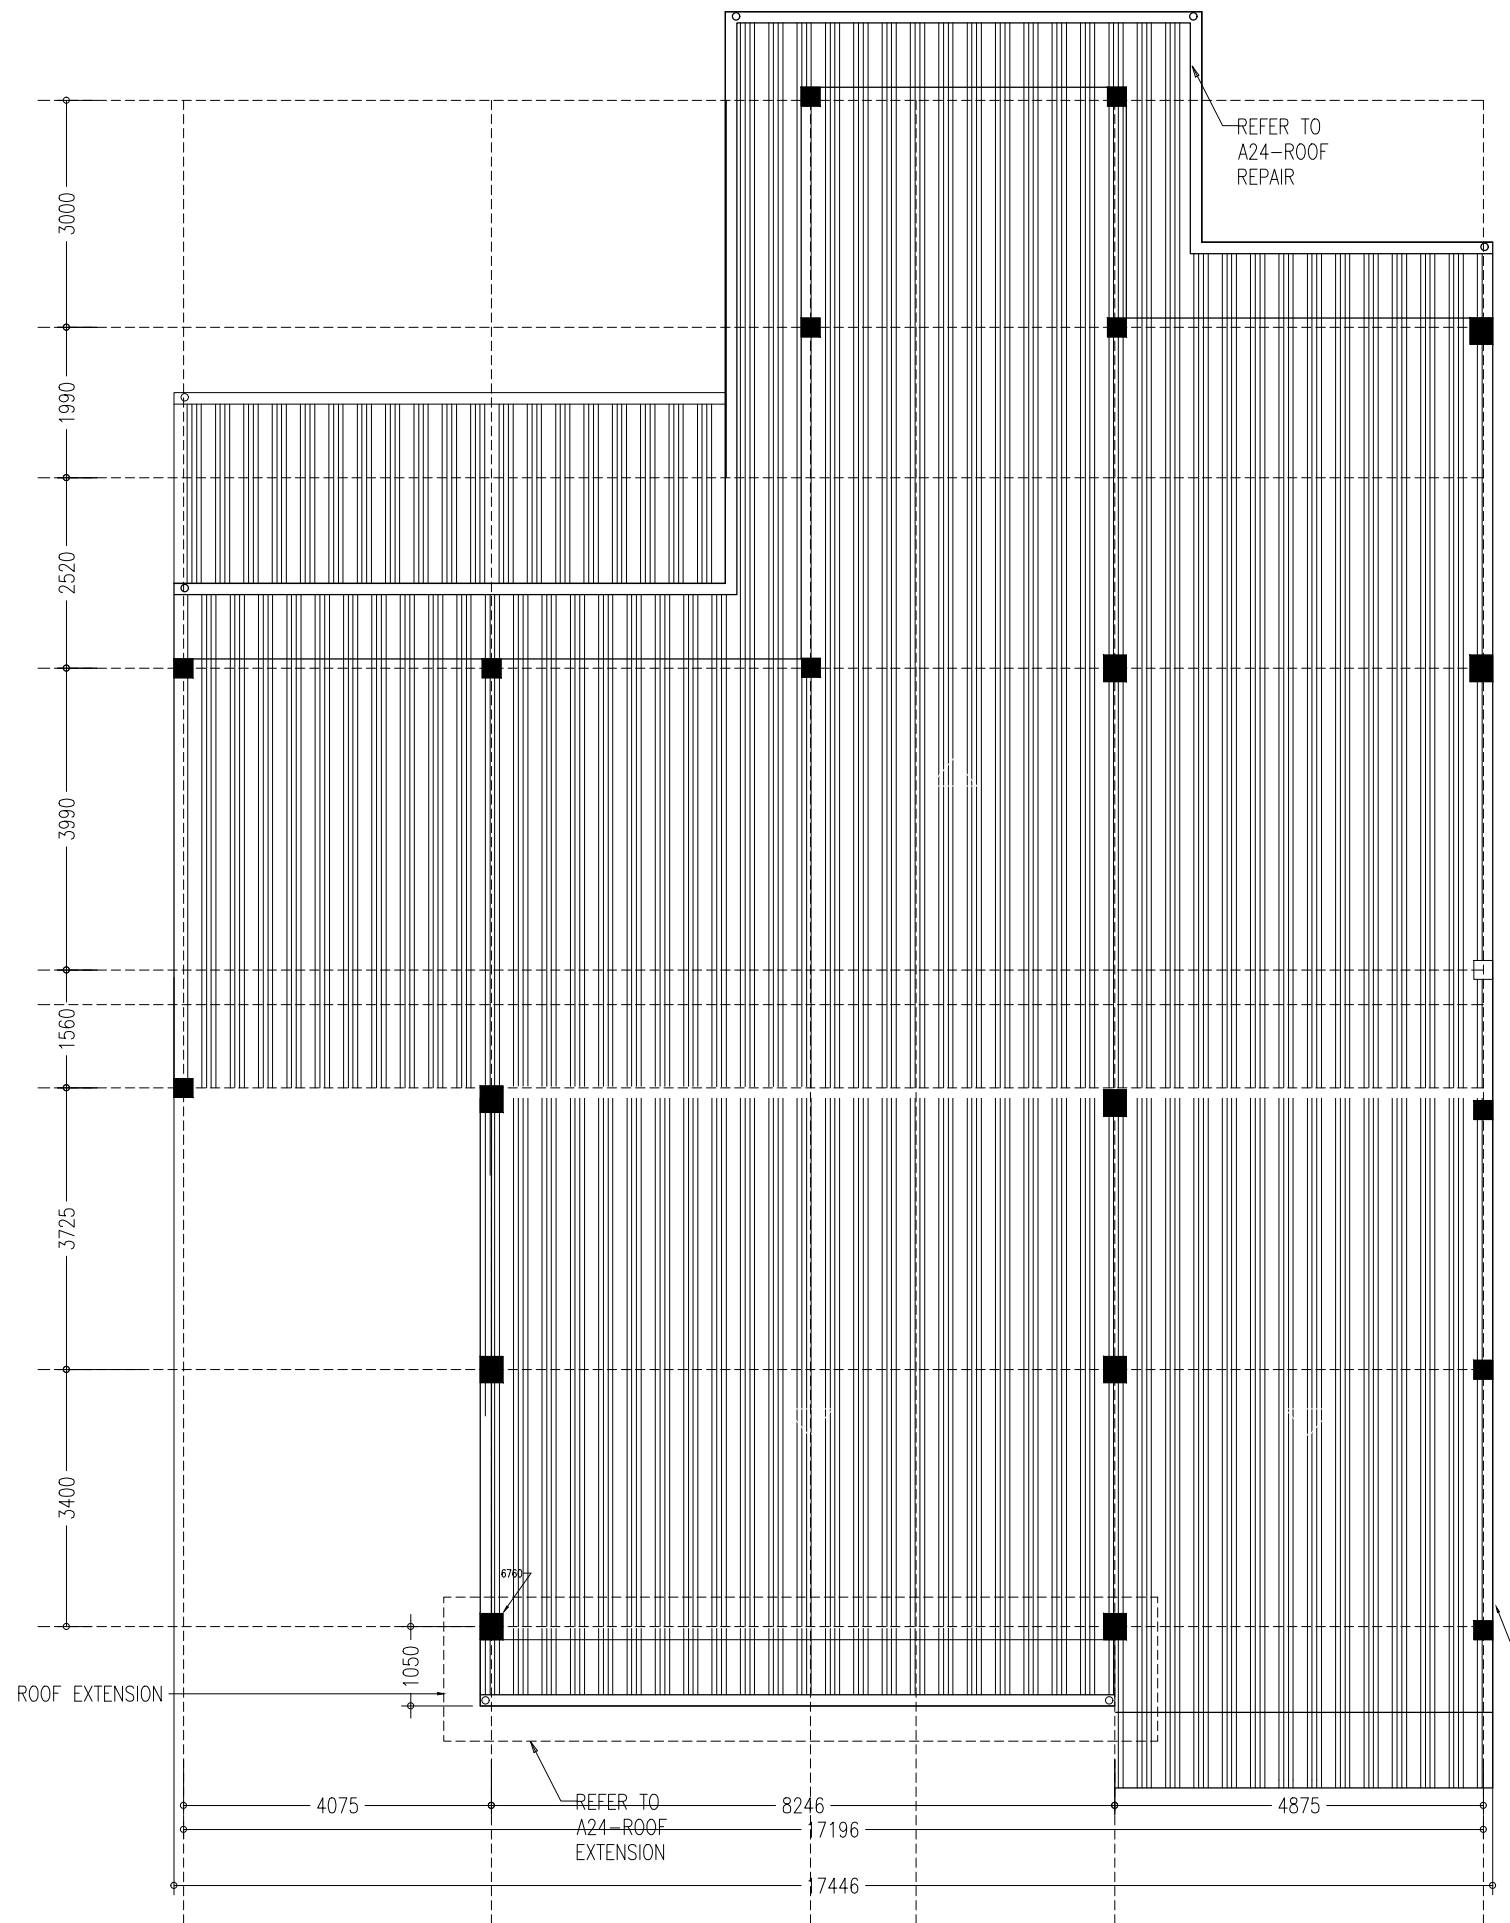

**ROOF PLAN - PROPOSED PLAN**  
SCALE 1:200




CONTRACTORS MUST CHECK ALL DIMENSIONS ON SITE BEFORE STARTING ANY WORK OR SHOP DRAWINGS. FIGURED DIMENSIONS TO TAKE PRECEDENCE OVER SCALE READINGS




REVISION:	ARCHITECT:	PROJECT:	MALDIVES POLYTECHNIC, SEENU. HITHADHOO CAMPUS
	ENGINEER:	LOCATION:	SEENU. HITHADHOO
	ARCHITECTURAL CHECKER:	DRAWING TITLE:	AS GIVEN
	STRUCTURAL CHECKER:	CLIENT:	MINISTRY OF HIGHER EDUCATION
	DRAWN BY: AISHATH HAMRA	SCALE: AS GIVEN	DIMENSION: MM
		DATE: SEPTMBER 2021	

**A-13**  
DWG NO  
PROJECT NO: 21-001


CONCEPT AND DESIGN IN THIS DRAWING ARE THE PROPERTIES OF ARCHENG STUDIO PVT LTD. UNAUTHORIZED USE OR REPRODUCTION OF PART OF THE DESIGN, DRAWINGS OR CONCEPT TO USE IN OTHER PROJECTS OR SITES OTHER THAN SPECIFIED ON THIS DRAWING IS PROHIBITED

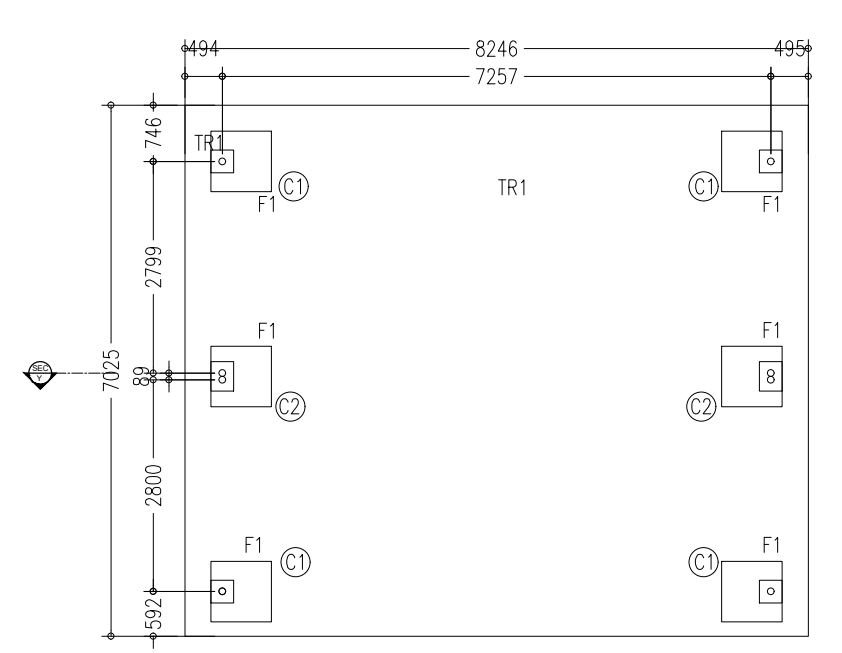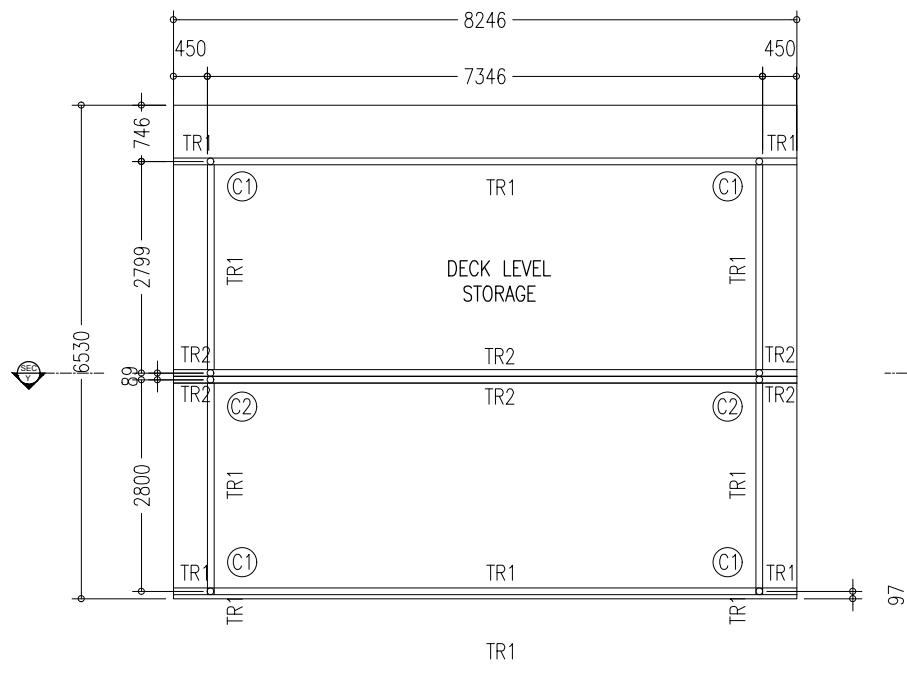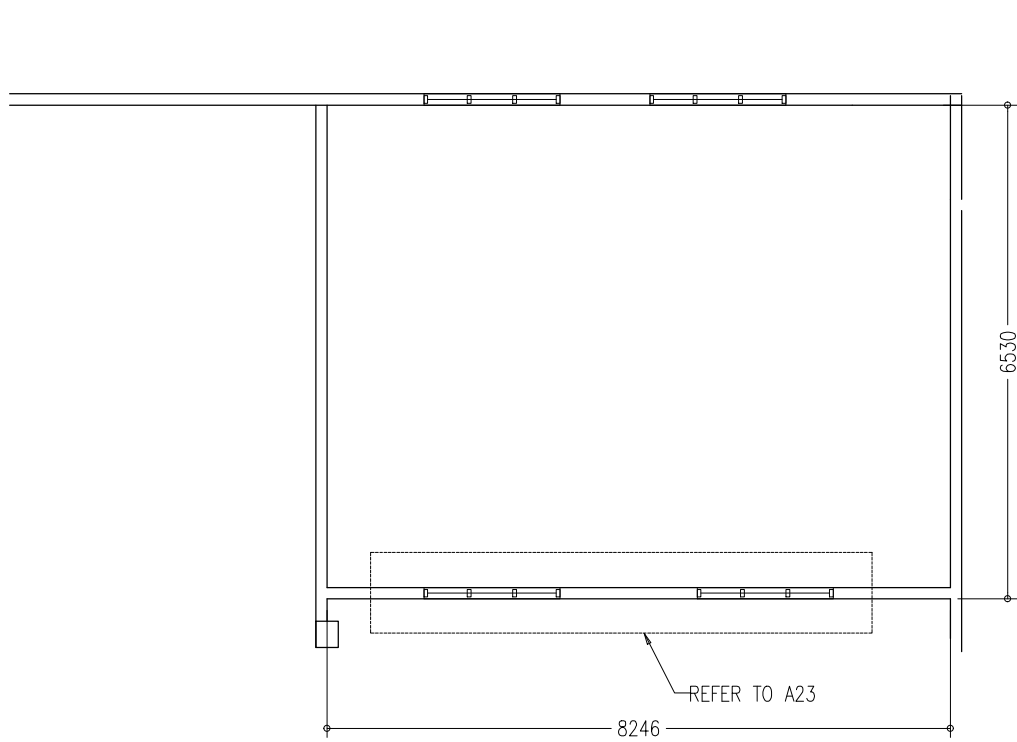

**DECK STRUCTURE PLAN**  
SCALE 1:100

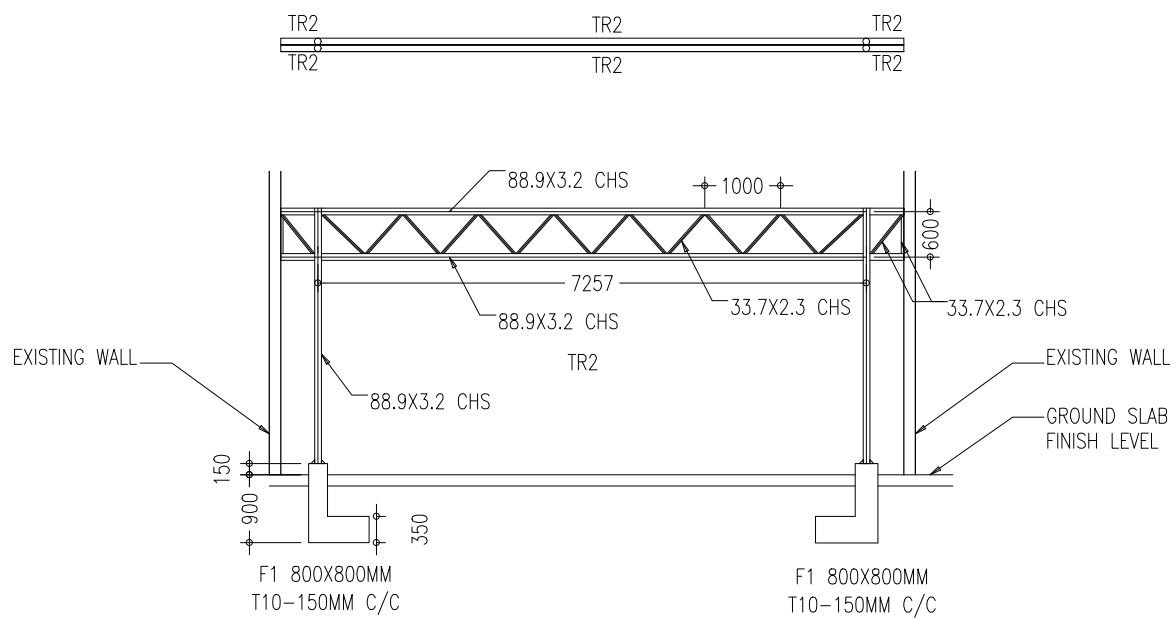

**TRUSS PLAN SECTION Y**  
SCALE 1:100

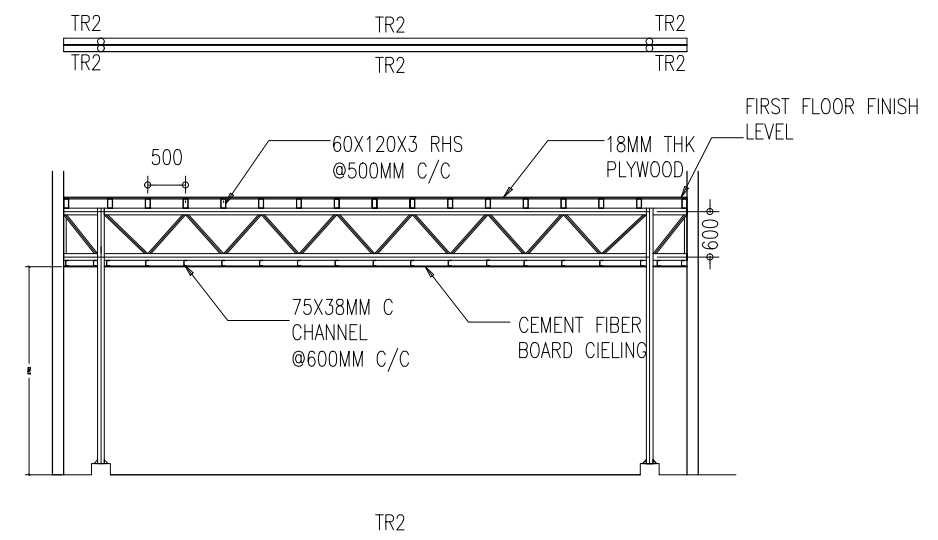

**DECK STRUCTURE PLAN**  
SCALE 1:100


CONTRACTORS MUST CHECK ALL DIMENSIONS ON SITE BEFORE STARTING ANY WORK OR SHOP DRAWINGS. FIGURED DIMENSIONS TO TAKE PRECEDENCE OVER SCALE READINGS





REVISION:	ARCHITECT:	PROJECT:	MALDIVES POLYTECHNIC, SEENU. HITHADHOO CAMPUS
	ENGINEER:	LOCATION:	SEENU. HITHADHOO
	ARCHITECTURAL CHECKER:	DRAWING TITLE:	AS GIVEN
	STRUCTURAL CHECKER:	CLIENT:	MINISTRY OF HIGHER EDUCATION
	DRAWN BY: AISHATH HAMRA	SCALE: AS GIVEN	DIMENSION: MM
		DATE: SEPTEMBER 2021	

**A-14**  
DWG NO  
PROJECT NO: 21-001


CONCEPT AND DESIGN IN THIS DRAWING ARE THE PROPERTIES OF ARCHENG STUDIO PVT LTD. UNAUTHORIZED USE OR REPRODUCTION OF PART OF THE DESIGN, DRAWINGS OR CONCEPT TO USE IN OTHER PROJECTS OR SITES OTHER THAN SPECIFIED ON THIS DRAWING IS PROHIBITED

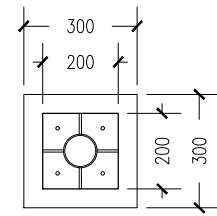


C1

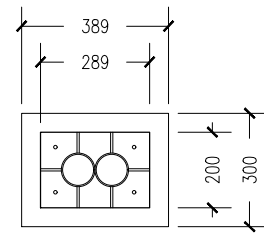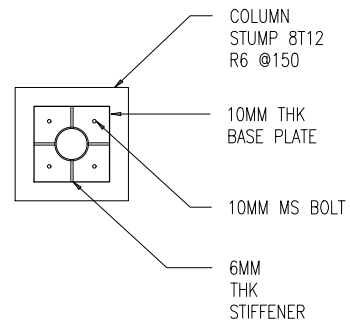


C2

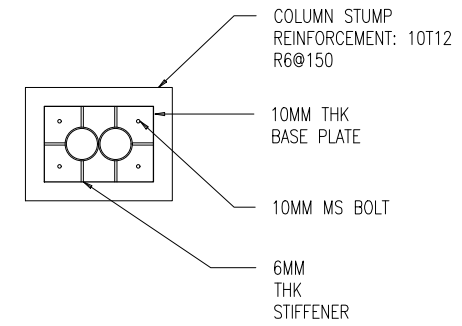


**COLUMN DETAIL**  
SCALE 1:20

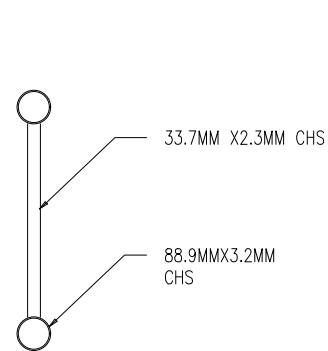

TR1

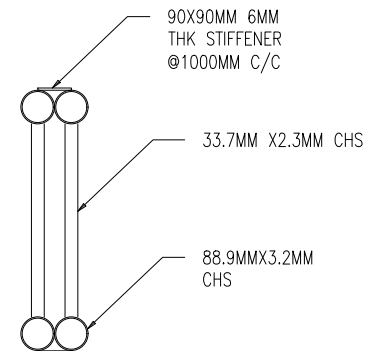

TR2

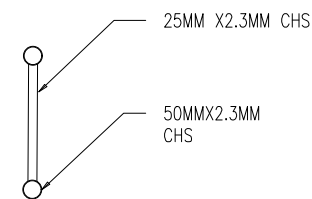

TR3

NOTE:- WELDED TO EXISTING TRUSS FOR WALL SUPPORT DEPTH OF TRUSS IS EQUAL TO EXISTING ROOF TRUSS

**TRUSS DETAIL**  
SCALE 1:20

CONTRACTORS MUST CHECK ALL DIMENSIONS ON SITE BEFORE STARTING ANY WORK OR SHOP DRAWINGS. FIGURED DIMENSIONS TO TAKE PRECEDENCE OVER SCALE READINGS




REVISION:	ARCHITECT:	PROJECT:	MALDIVES POLYTECHNIC, SEENU. HITHADHOO CAMPUS
	ENGINEER:	LOCATION:	SEENU. HITHADHOO
	ARCHITECTURAL CHECKER:	DRAWING TITLE:	AS GIVEN
	STRUCTURAL CHECKER:	CLIENT:	MINISTRY OF HIGHER EDUCATION
	DRAWN BY: AISHATH HAMRA	SCALE: AS GIVEN	DIMENSION: MM
		DATE: SEPTMBER 2021	PROJECT NO: 21-001

**A-15**

DWG NO




CONCEPT AND DESIGN IN THIS DRAWING ARE THE PROPERTIES OF ARCHENG STUDIO PVT LTD. UNAUTHORIZED USE OR REPRODUCTION OF PART OF THE DESIGN, DRAWINGS OR CONCEPT TO USE IN OTHER PROJECTS OR SITES OTHER THAN SPECIFIED ON THIS DRAWING IS PROHIBITED



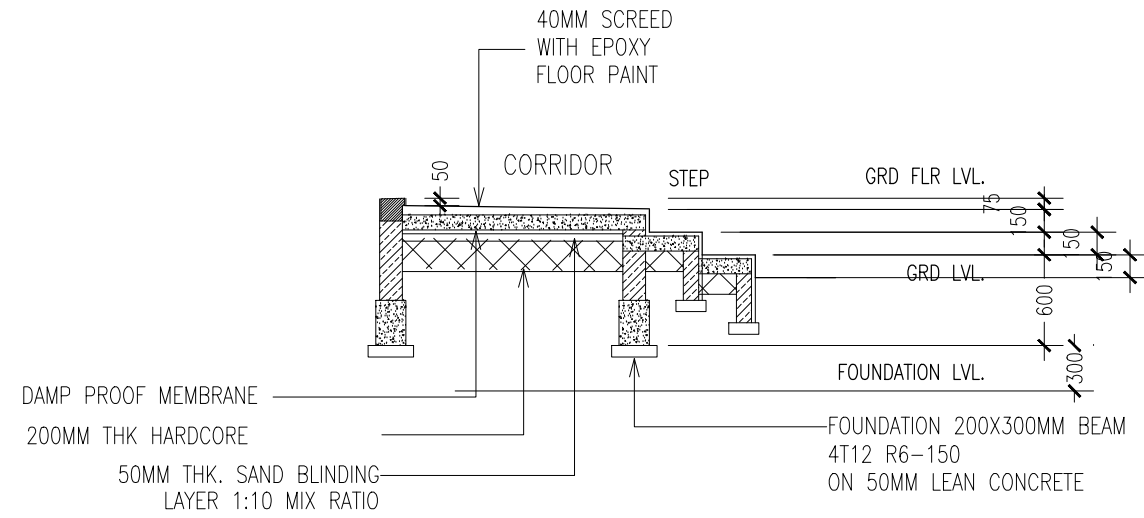

**GROUND SLAB PLAN**

SCALE 1:50

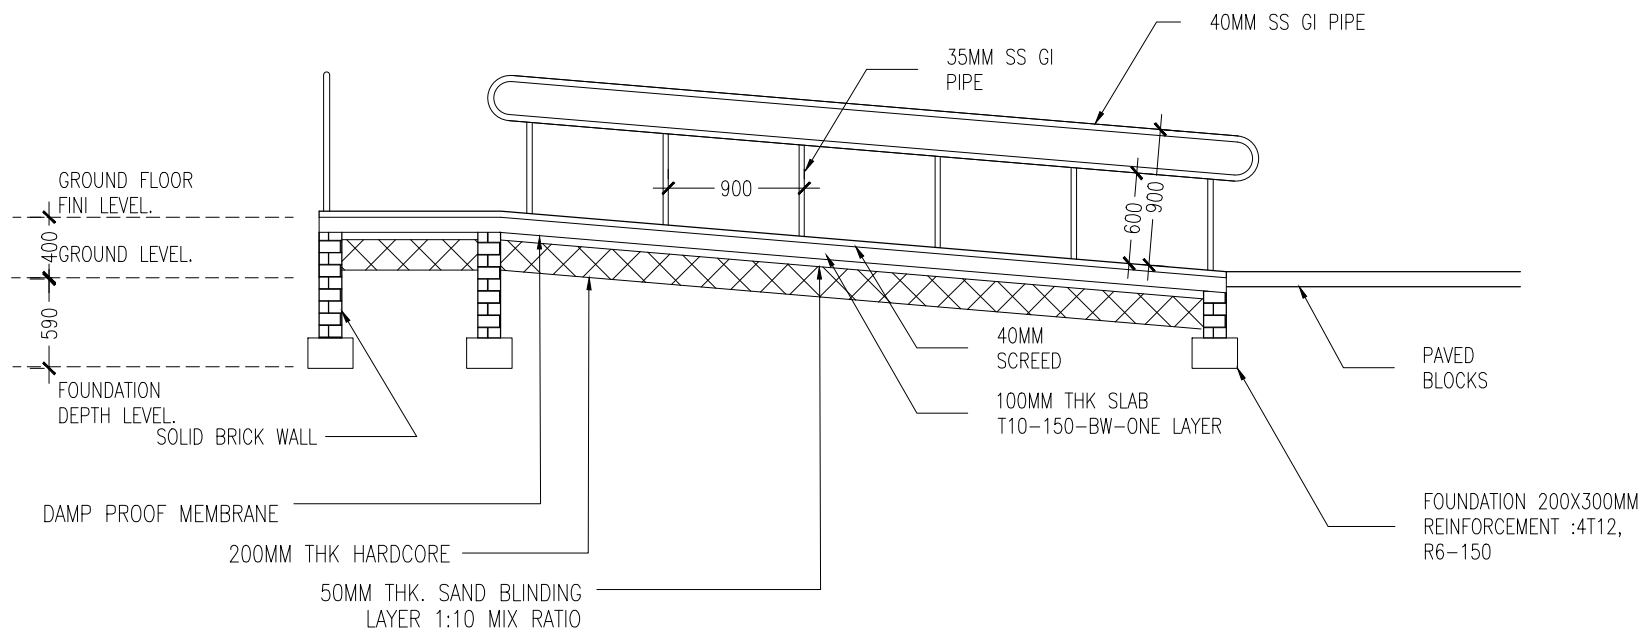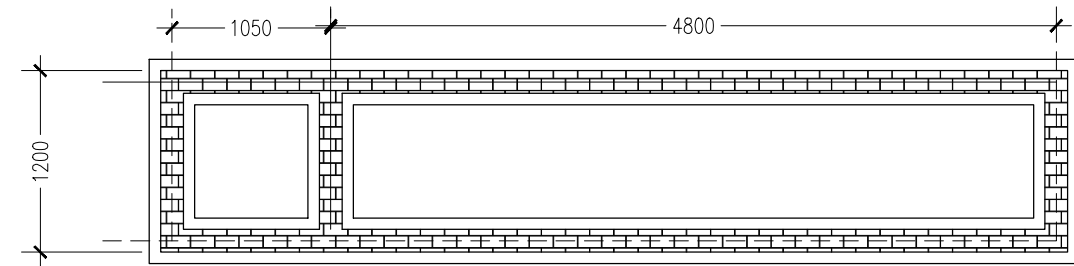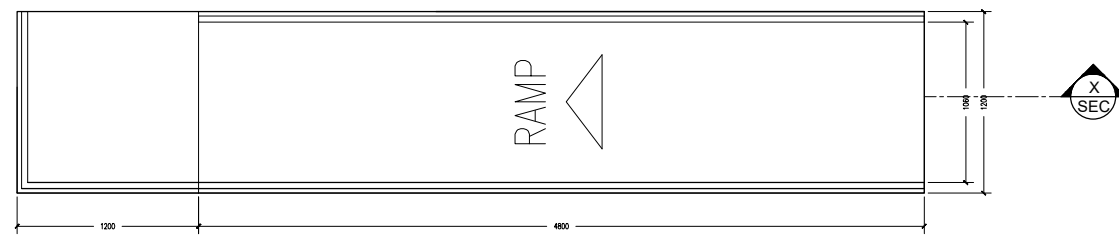

**RAMP DETAIL PLAN**

SCALE 1:50

CONTRACTORS MUST CHECK ALL DIMENSIONS ON SITE BEFORE STARTING ANY WORK OR SHOP DRAWINGS. FIGURED DIMENSIONS TO TAKE PRECEDENCE OVER SCALE READINGS




REVISION:	ARCHITECT:	PROJECT:	MALDIVES POLYTECHNIC, SEENU. HITHADHOO CAMPUS
	ENGINEER:	LOCATION:	SEENU. HITHADHOO
	ARCHITECTURAL CHECKER:	DRAWING TITLE:	AS GIVEN
	STRUCTURAL CHECKER:	CLIENT:	MINISTRY OF HIGHER EDUCATION
	DRAWN BY: AISHATH HAMRA	SCALE: AS GIVEN	DIMENSION: MM
		DATE: SEPTEMBER 2021	

**A-16**


DWG NO

PROJECT NO: 21-001

CONCEPT AND DESIGN IN THIS DRAWING ARE THE PROPERTIES OF ARCHENG STUDIO PVT LTD. UNAUTHORIZED USE OR REPRODUCTION OF PART OF THE DESIGN, DRAWINGS OR CONCEPT TO USE IN OTHER PROJECTS OR SITES OTHER THAN SPECIFIED ON THIS DRAWING IS PROHIBITED

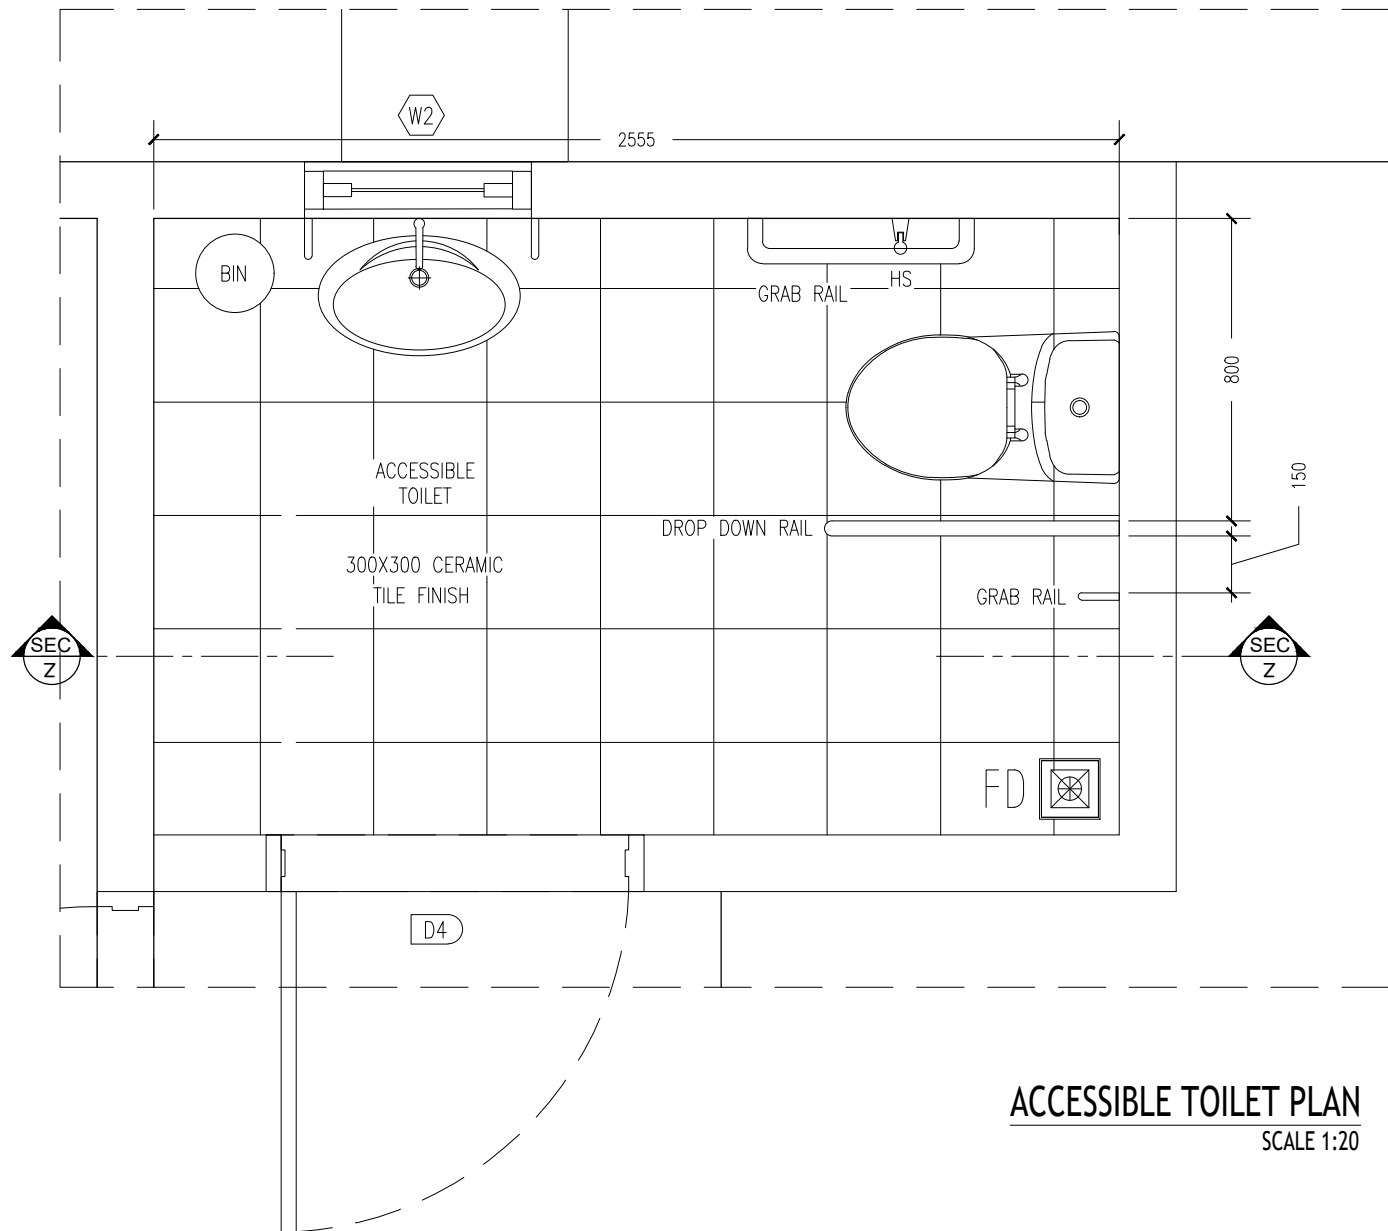

**ACCESSIBLE TOILET PLAN**  
SCALE 1:20

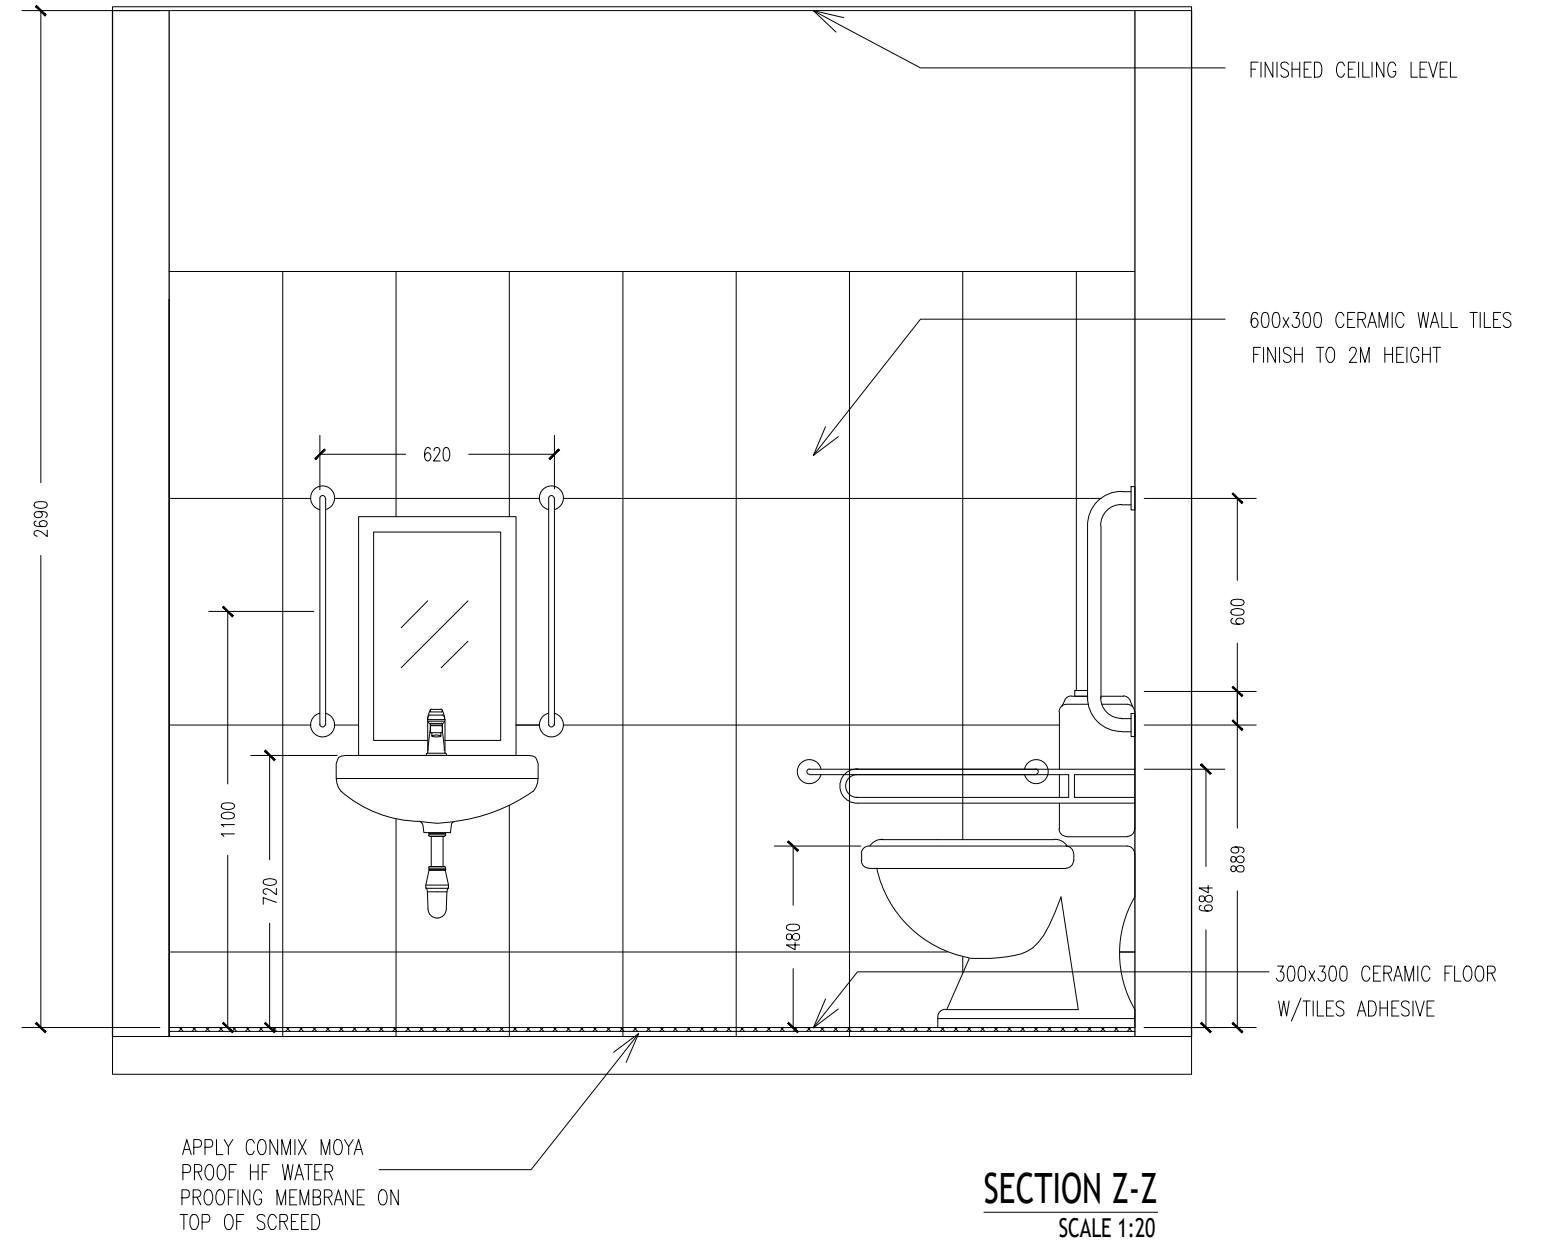

**SECTION Z-Z**  
SCALE 1:20

CONTRACTORS MUST CHECK ALL DIMENSIONS ON SITE BEFORE STARTING ANY WORK OR SHOP DRAWINGS. FIGURED DIMENSIONS TO TAKE PRECEDENCE OVER SCALE READINGS




REVISION:	ARCHITECT:	PROJECT:	MALDIVES POLYTECHNIC, SEENU. HITHADHOO CAMPUS
	ENGINEER:	LOCATION:	SEENU. HITHADHOO
	ARCHITECTURAL CHECKER:	DRAWING TITLE:	AS GIVEN
	STRUCTURAL CHECKER:	CLIENT:	MINISTRY OF HIGHER EDUCATION
	DRAWN BY: AISHATH HAMRA	SCALE: AS GIVEN	DIMENSION: MM
		DATE: SEPTEMBER 2021	


**A-17**

DWG NO  
PROJECT NO: 21-001


CONCEPT AND DESIGN IN THIS DRAWING ARE THE PROPERTIES OF ARCHENG STUDIO PVT LTD. UNAUTHORIZED USE OR REPRODUCTION OF PART OF THE DESIGN, DRAWINGS OR CONCEPT TO USE IN OTHER PROJECTS OR SITES OTHER THAN SPECIFIED ON THIS DRAWING IS PROHIBITED

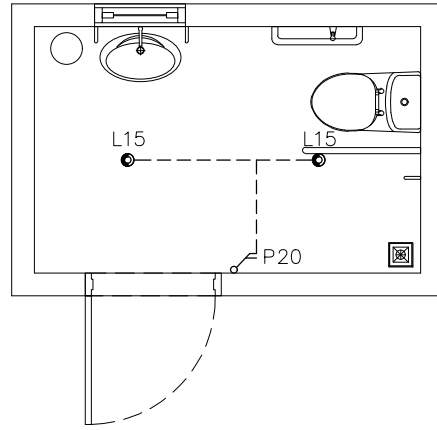

**ACCESSIBLE TOILET LIGHTING LAUOUT PLAN**  
SCALE 1:50

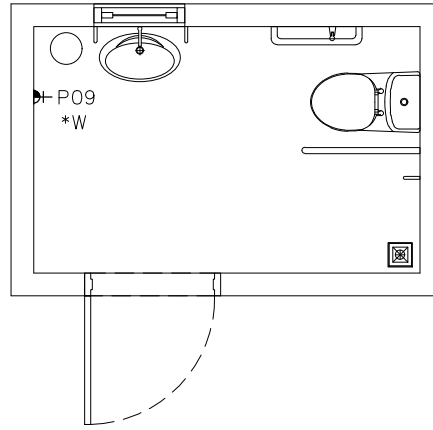

**ACCESSIBLE TOILET SOCKET LAUOUT PLAN**  
SCALE 1:50

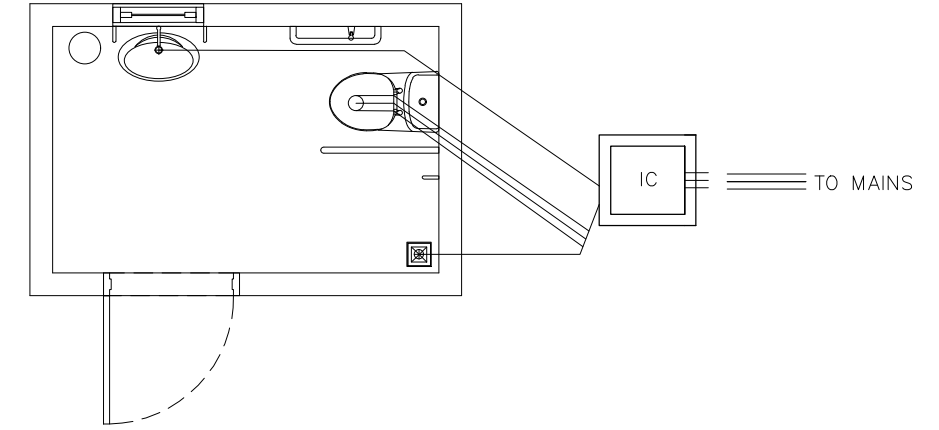

**ACCESSIBLE TOILET SEWAGE & WASTE DISPOSAL PLAN**  
SCALE 1:50

**LIGHTING LEGEND**

●	L15	1X16W ENERGY SAVING SLAB MOUNT WARM COMPACT FLUORESCENT LAMPS IN RECESSED DECORATIVE LUMINAIRE
---	-----	--

**SWITCHS LEGEND**

⏏	P20	2GANG 1 WAY SWITCH
---	-----	--------------------


**ELECTRICAL LEGEND**

SYMBOL	CODE	DESCRIPTION
⏏	P09	1 GANG13A SOCKET OUTLET AT 1200mm ABOVE FINISHED FLOOR LEVEL

\*W SOCKET INSTALLED INSIDE WEATHER PROOF COVER

**LEGEND**

SYMBOL	DESCRIPTION
↗	TAP
→	MUSLIM SHOWER
-----	WATER SUPPLY (ø12-ø35)
⊠	FLOOR DRAIN
———	UPVC HIGH PRESSURE WASTE WATER PIPE (ø75-ø100)
≡≡≡	SEWAGE DISPOSAL (ø100-ø150)
IC	INSPECTION CHAMBER

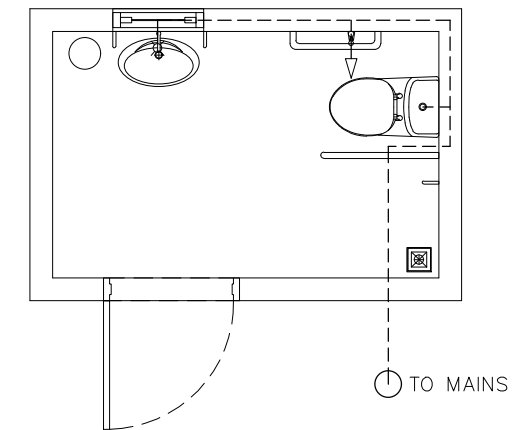

**ACCESSIBLE TOILET FRESH WATER SUPPLY PLAN**  
SCALE 1:50

CONTRACTORS MUST CHECK ALL DIMENSIONS ON SITE BEFORE STARTING ANY WORK OR SHOP DRAWINGS. FIGURED DIMENSIONS TO TAKE PRECEDENCE OVER SCALE READINGS







REVISION:	ARCHITECT:	PROJECT:	MALDIVES POLYTECHNIC, SEENU. HITHADHOO CAMPUS
	ENGINEER:	LOCATION:	SEENU. HITHADHOO
	ARCHITECTURAL CHECKER:	DRAWING TITLE:	AS GIVEN
	STRUCTURAL CHECKER:	CLIENT:	MINISTRY OF HIGHER EDUCATION
	DRAWN BY: AISHATH HAMRA	SCALE: AS GIVEN	DIMENSION: MM
		DATE: SEPTMBER 2021	PROJECT NO: 21-001

**A-18**

DWG NO

CONCEPT AND DESIGN IN THIS DRAWING ARE THE PROPERTIES OF ARCHENG STUDIO PVT LTD. UNAUTHORIZED USE OR REPRODUCTION OF PART OF THE DESIGN, DRAWINGS OR CONCEPT TO USE IN OTHER PROJECTS OR SITES OTHER THAN SPECIFIED ON THIS DRAWING IS PROHIBITED

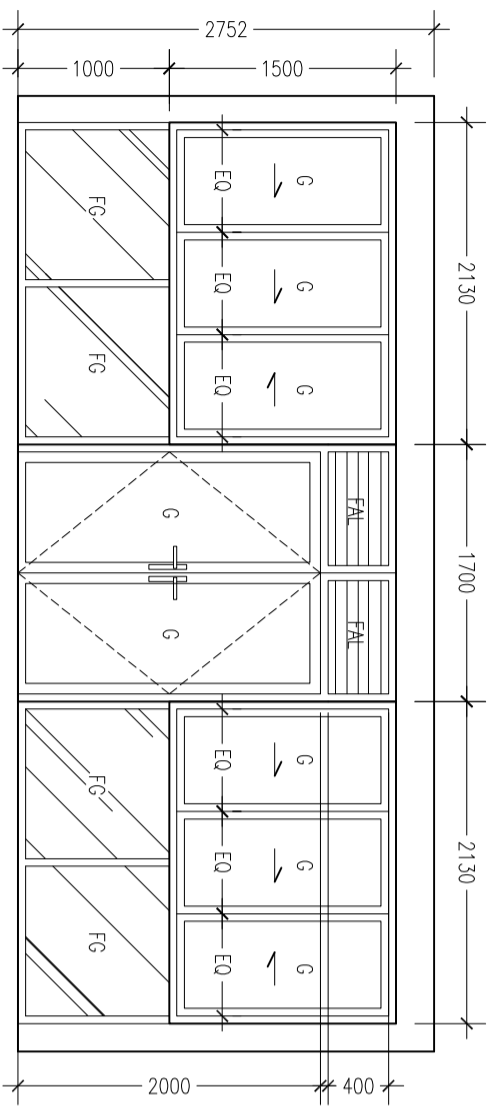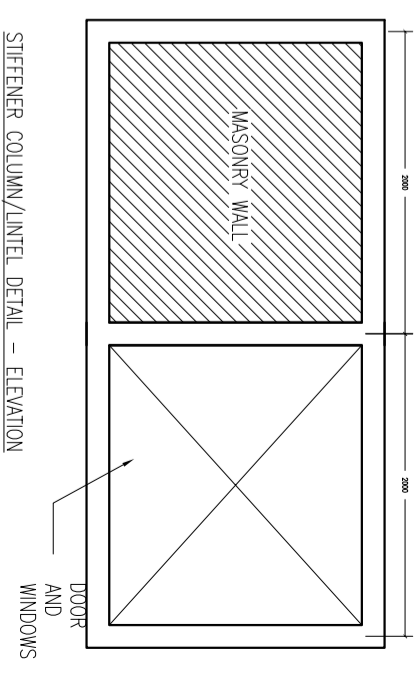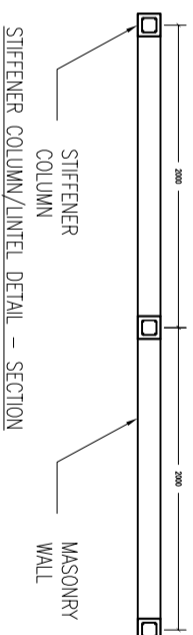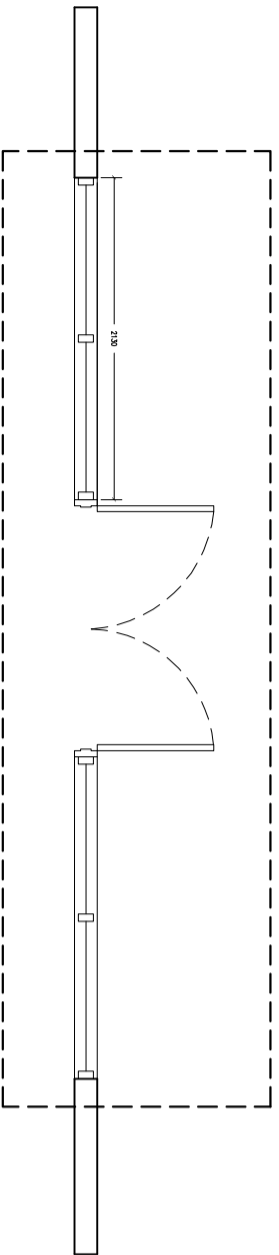

**PROPOSED ENTRANCE**  
SCALE 1:50

CONTRACTORS MUST CHECK ALL DIMENSIONS ON SITE BEFORE STARTING ANY WORK OR SHOP DRAWINGS. FIGURED DIMENSIONS TO TAKE PRECEDENCE OVER SCALE REMAININGS



REVISION:	ARCHITECT:	PROJECT:	MALDIVES POLYTECHNIC, SEENU, HITHADHOO CAMPUS
	ENGINEER:	LOCATION:	SEENU, HITHADHOO
	ARCHITECTURAL CHECKER:	DRAWING TITLE:	AS GIVEN
	STRUCTURAL CHECKER:	CLIENT:	MINISTRY OF HIGHER EDUCATION
	DRAWN BY:	SCALE:	AS GIVEN
	ASHATHI HAMRA	DIMENSION:	MM
		DATE:	SEPTEMBER 2021
		PROJECT NO.:	21-001

**A-19**


CONCEPT AND DESIGN IN THIS DRAWING ARE THE PROPERTIES OF ARCHENG STUDIO PVT.LTD. UNAUTHORIZED USE OR REPRODUCTION OF PART OF THE DESIGN DRAWINGS OR CONCEPT TO USE IN OTHER PROJECTS OR SITES OTHER THAN SPECIFIED ON THIS DRAWING IS PROHIBITED

ELEVATIONS :			
	FINISH FLOOR LEVEL		
DR / WD NO.	D1A	D3	D4
DESCRIPTION :	40MM THICK OPENABLE ALUMINIUM DOOR PANEL WITH SLIDING WINDOWS AND FIXED GLASS	40MM THICK OPENABLE READY MADE SOLID TIMBER DOOR PANELS	40MM THICK OPENABLE ALUMINIUM DOOR PANEL
FRAME :	40 MICRON WHITE POWDER COATED ALUMINIUM FRAME	120MM TIMBER FRAME	120MM TIMBER FRAME
HARDWARE :	DOOR CLOSER LOCK BUTT HINGE STOPPER HOLDER	01 NO. OPENABLE DOOR PANEL 04 NOS. HINGES 01 NO. LOCK	DOOR CLOSER LATCH LOCK AND SS DOOR HANDLE BUTT HINGE STOPPER HOLDER
GLAZING :	6MM THICK CLEAR GLASS	-	-

### PROPOSED DOOR/WINDOW SCHEDULE

SCALE 1:50


CONTRACTORS MUST CHECK ALL DIMENSIONS ON SITE BEFORE STARTING ANY WORK OR SHOP DRAWINGS. FIGURED DIMENSIONS TO TAKE PRECEDENCE OVER SCALE READINGS

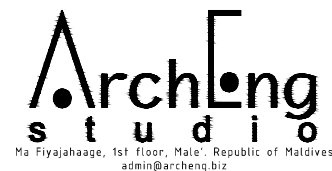

REVISION:	ARCHITECT:	PROJECT:	MALDIVES POLYTECHNIC, SEENU. HITHADHOO CAMPUS
	ENGINEER:	LOCATION:	SEENU. HITHADHOO
	ARCHITECTURAL CHECKER:	DRAWING TITLE:	AS GIVEN
	STRUCTURAL CHECKER:	CLIENT:	MINISTRY OF HIGHER EDUCATION
	DRAWN BY: AISHATH HAMRA	SCALE: AS GIVEN	DIMENSION: MM
		DATE: SEPTMBER 2021	PROJECT NO: 21-001

**A-20**

DWG NO

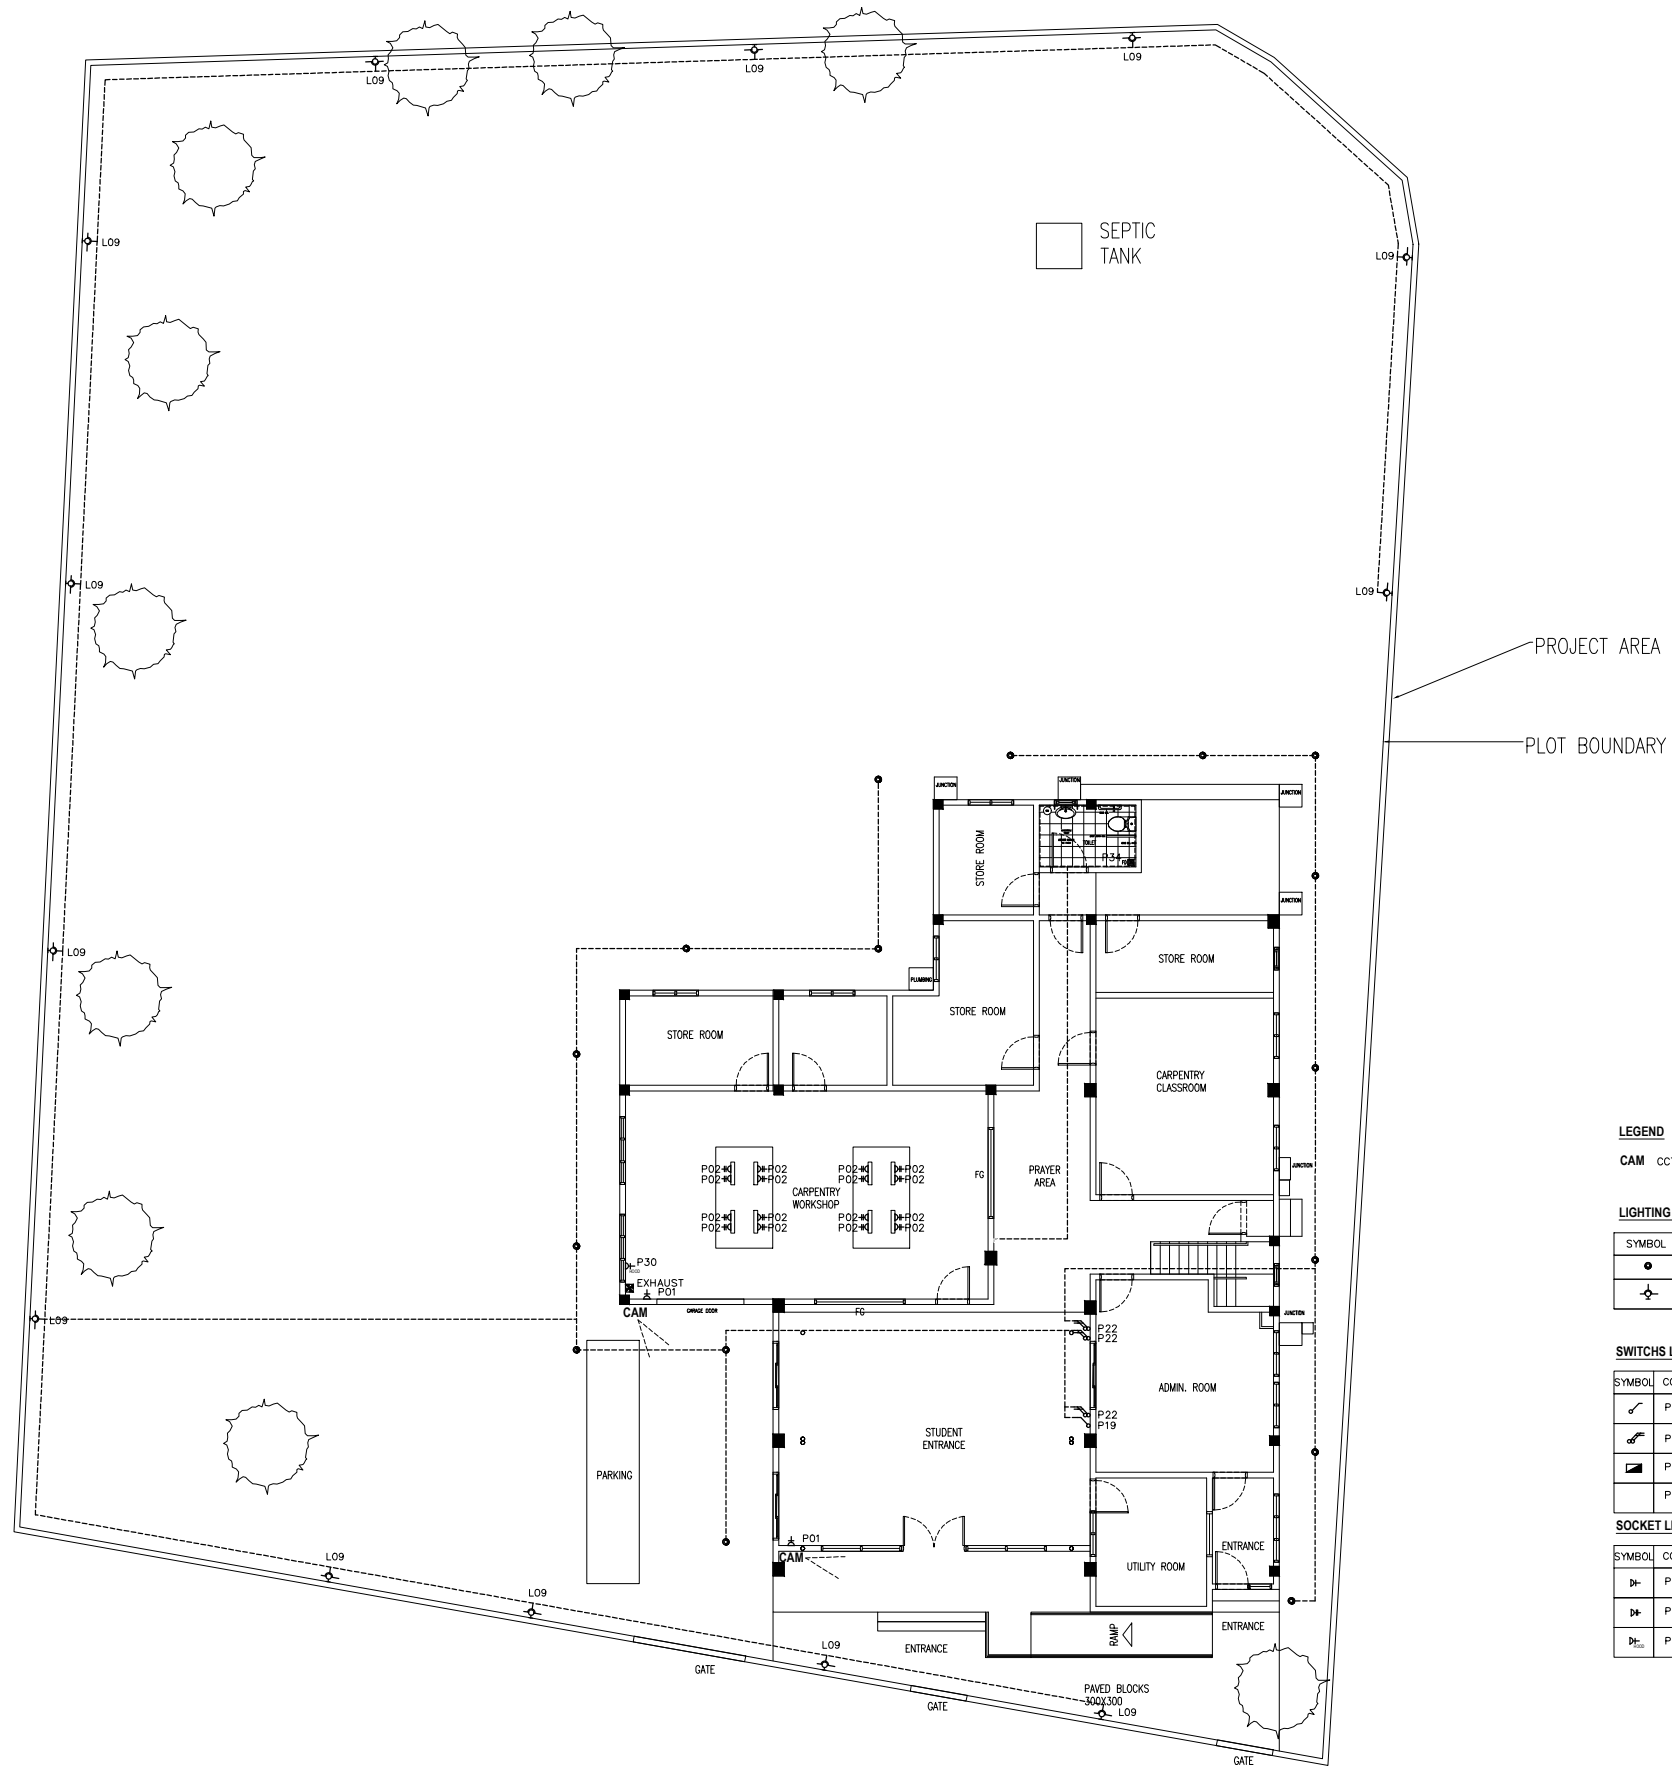

**LEGEND**

**CAM** CCTV CAMERA

**LIGHTING LEGEND**

SYMBOL	CODE	DESCRIPTION
●		WHITE LED GARDEN LIGHT
⊕	L09	1X26W COMPACT FLUORESCENT LAMPS IN SURFACE MOUNT DECORATIVE LUMINAIRE

**SWITCHES LEGEND**

SYMBOL	CODE	DESCRIPTION
⎓	P19	1 GANG 1 WAY SWITCH
⎓	P22	4 GANG 1 WAY SWITCH
⎓	P33	DISTRIBUTION BOARD
⎓	P34	REMOTE INDICATOR ALARM CHORD 300 MM ABOVE FLOOR FINISH LEVEL

**SOCKET LEGEND**

SYMBOL	CODE	DESCRIPTION
⎓	P01	1 GANG13A SOCKET OUTLET AT 300mm ABOVE FINISHED FLOOR LEVEL
⎓	P02	2 GANG13A SOCKET OUTLET AT GROUND LEVEL
⎓	P30	1 GANG13A SOCKET OUTLET AT CEILING LEVEL FOR KITCHEN HOOD /EXHAUST - 2.1 METERS FFL

**SITE PLAN - PROPOSED PLAN**

SCALE 1:200

CONTRACTORS MUST CHECK ALL DIMENSIONS ON SITE BEFORE STARTING ANY WORK OR SHOP DRAWINGS. FIGURED DIMENSIONS TO TAKE PRECEDENCE OVER SCALE READINGS




REVISION:	ARCHITECT:	PROJECT:	MALDIVES POLYTECHNIC, SEENU. HITHADHOO CAMPUS
	ENGINEER:	LOCATION:	SEENU. HITHADHOO
	ARCHITECTURAL CHECKER:	DRAWING TITLE:	AS GIVEN
	STRUCTURAL CHECKER:	CLIENT:	MINISTRY OF HIGHER EDUCATION
	DRAWN BY: AISHATH HAMRA	SCALE: AS GIVEN	DIMENSION: MM
		DATE: SEPTEMBER 2021	

**A-21**

DWG NO

PROJECT NO: 21-001

CONCEPT AND DESIGN IN THIS DRAWING ARE THE PROPERTIES OF ARCHENG STUDIO PVT LTD. UNAUTHORIZED USE OR REPRODUCTION OF PART OF THE DESIGN, DRAWINGS OR CONCEPT TO USE IN OTHER PROJECTS OR SITES OTHER THAN SPECIFIED ON THIS DRAWING IS PROHIBITED

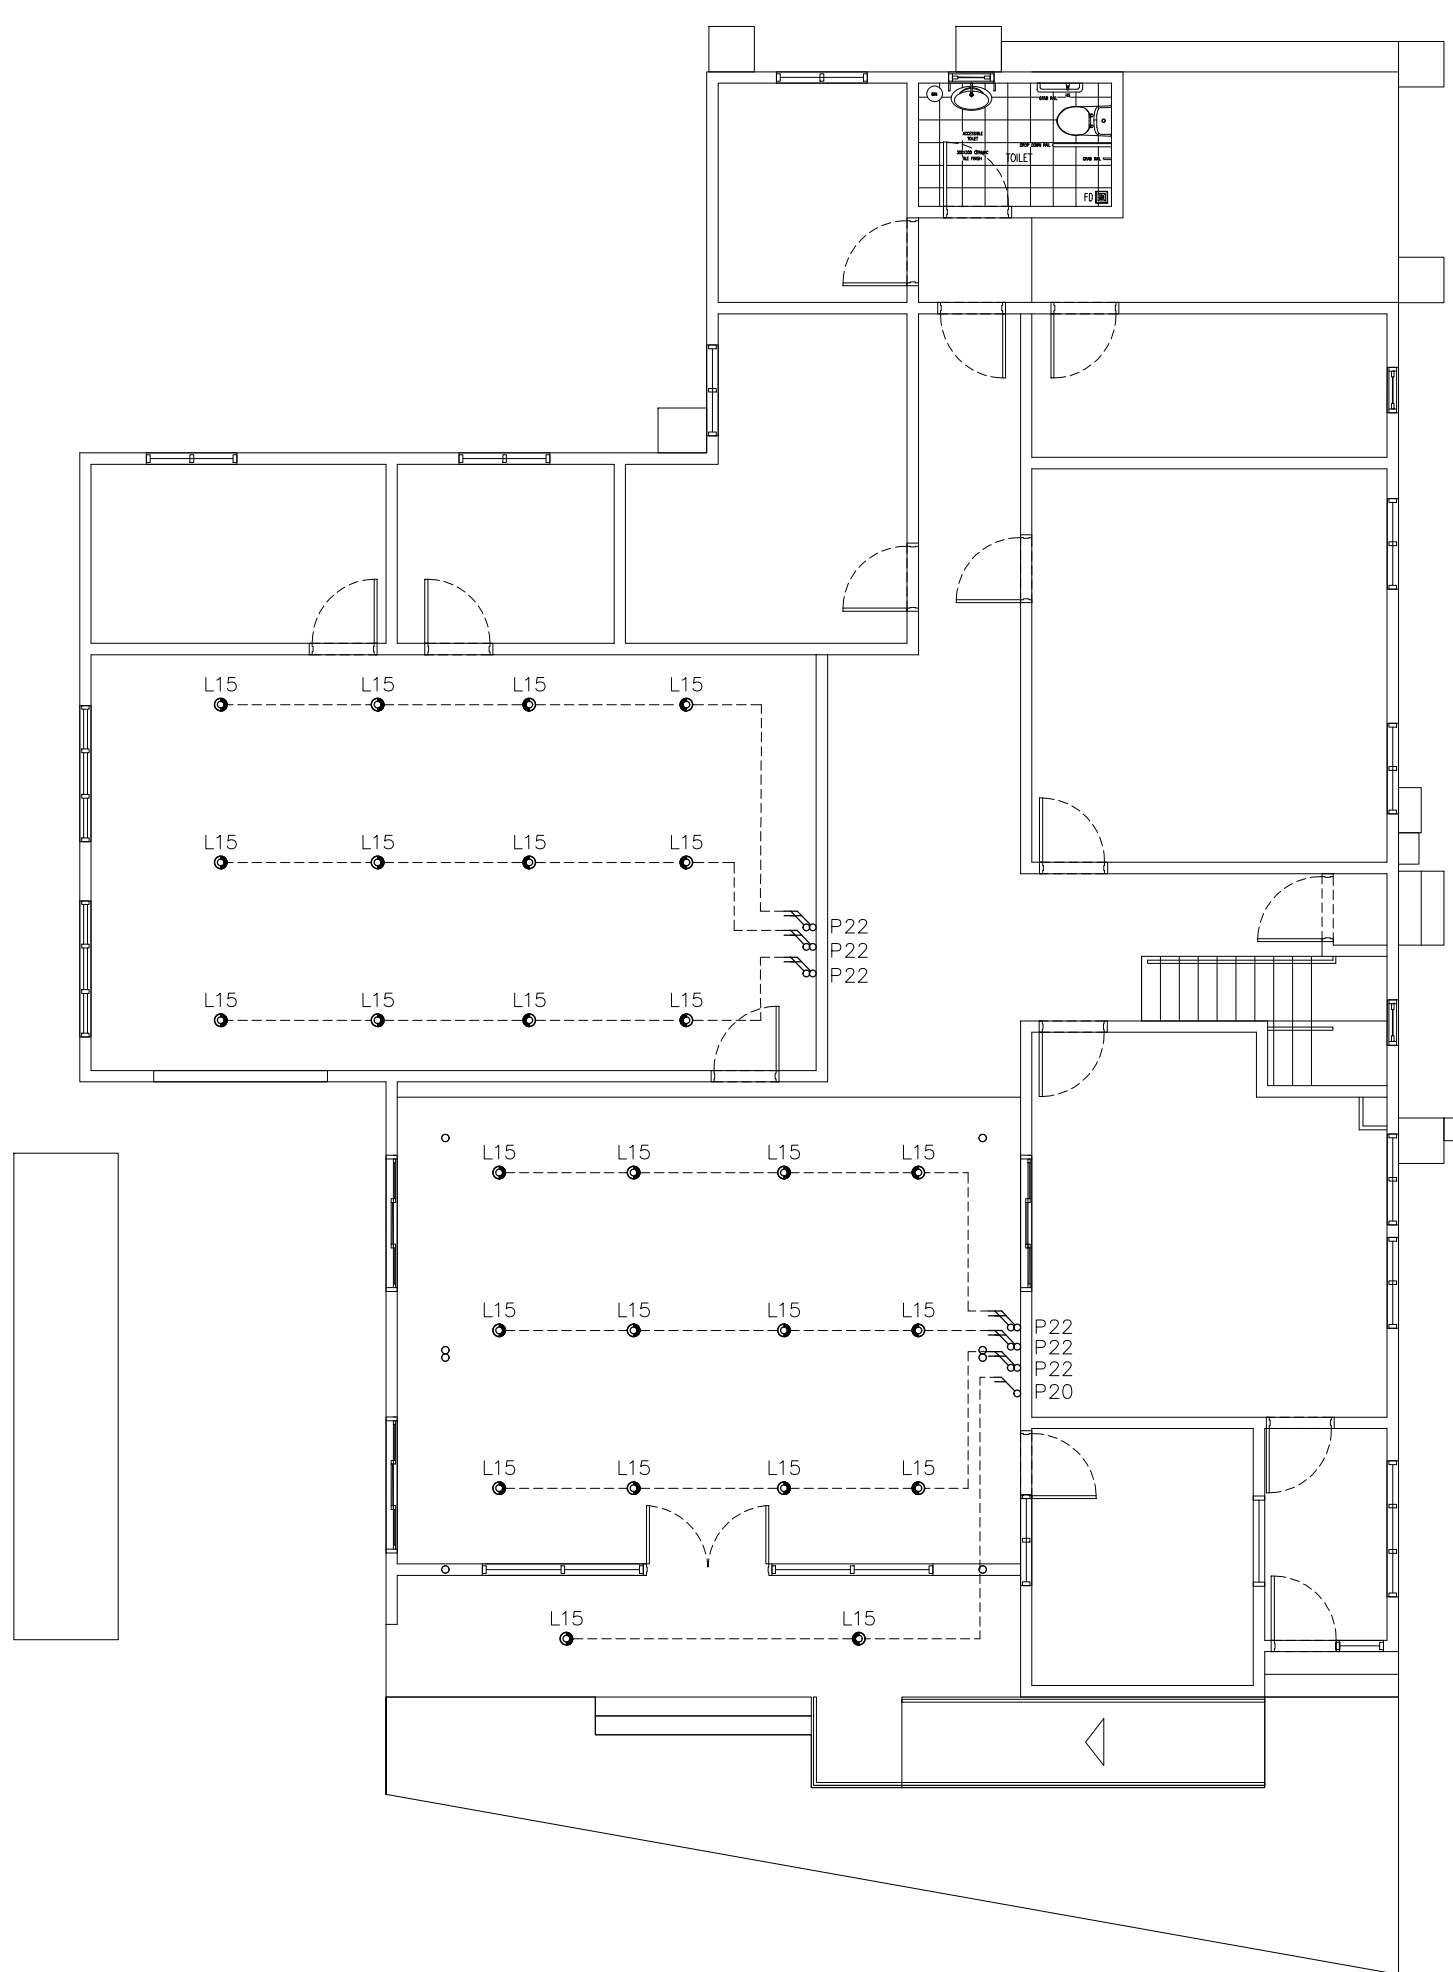

**LIGHTING LEGEND**

SYMBOL	CODE	DESCRIPTION
●	L15	1X16W ENERGY SAVING SLAB MOUNT WARM COMPACT FLUORESCENT LAMPS IN RECESSED DECORATIVE LUMINAIRE


**SWITCHES LEGEND**

SYMBOL	CODE	DESCRIPTION
⌚	P20	2 GANG 1 WAY SWITCH
⌚	P22	4 GANG 1 WAY SWITCH

**GROUND FLOOR PLAN - PROPOSED PLAN**

SCALE 1:100

CONTRACTORS MUST CHECK ALL DIMENSIONS ON SITE BEFORE STARTING ANY WORK OR SHOP DRAWINGS. FIGURED DIMENSIONS TO TAKE PRECEDENCE OVER SCALE READINGS



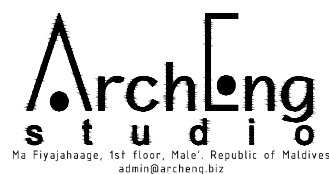


REVISION:  
 \_\_\_\_\_  
 \_\_\_\_\_  
 \_\_\_\_\_

ARCHITECT:  
 ENGINEER:  
 ARCHITECTURAL CHECKER:  
 STRUCTURAL CHECKER:  
 DRAWN BY: AISHATH HAMRA

PROJECT: MALDIVES POLYTECHNIC, SEENU. HITHADHOO CAMPUS  
 LOCATION: SEENU. HITHADHOO  
 DRAWING TITLE: AS GIVEN  
 CLIENT: MINISTRY OF HIGHER EDUCATION  
 SCALE: AS GIVEN    DIMENSION: MM    DATE: SEPTMBER 2021

**A-22**  
 DWG NO  
 PROJECT NO: 21-001

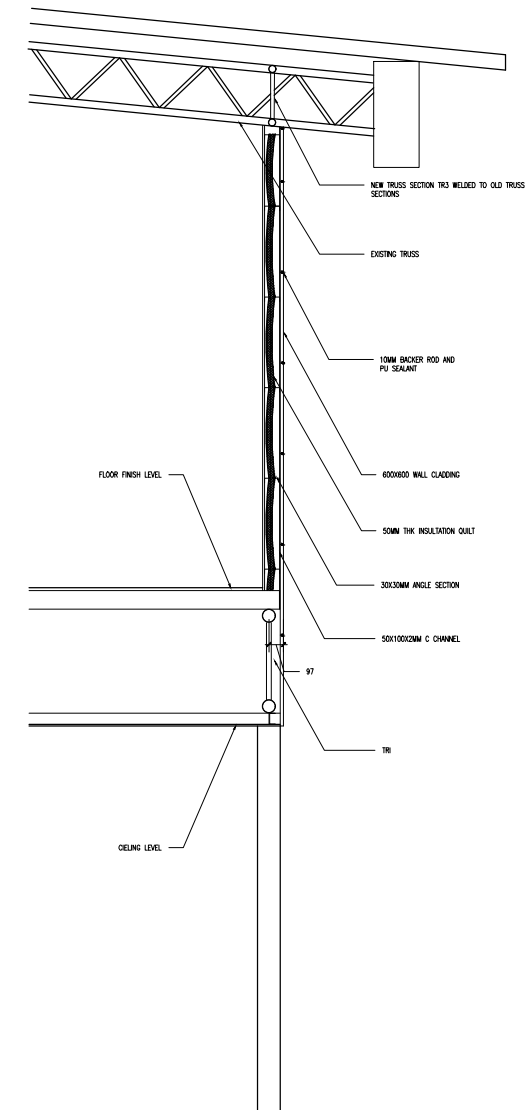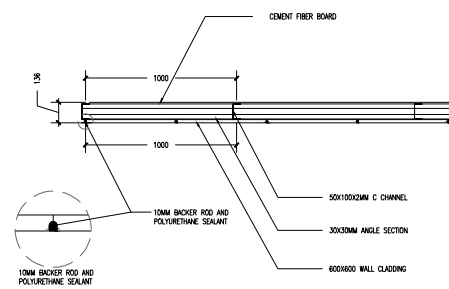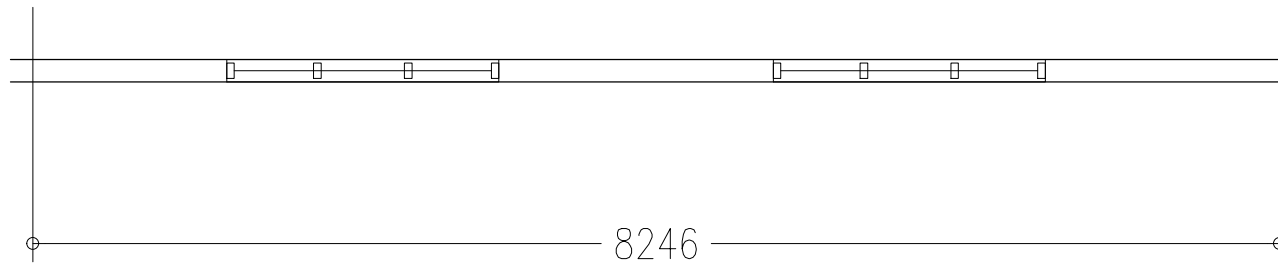

**DECK LEVEL EXTERIOR WALL AND CLADDING DETAIL**  
SCALE 1:50

CONTRACTORS MUST CHECK ALL DIMENSIONS ON SITE BEFORE STARTING ANY WORK OR SHOP DRAWINGS. FIGURED DIMENSIONS TO TAKE PRECEDENCE OVER SCALE READINGS



REVISION:	ARCHITECT:	PROJECT:	MALDIVES POLYTECHNIC, SEENU. HITHADHOO CAMPUS
	ENGINEER:	LOCATION:	SEENU. HITHADHOO
	ARCHITECTURAL CHECKER:	DRAWING TITLE:	AS GIVEN
	STRUCTURAL CHECKER:	CLIENT:	MINISTRY OF HIGHER EDUCATION
	DRAWN BY: AISHATH HAMRA	SCALE: AS GIVEN	DIMENSION: MM
		DATE: SEPTMBER 2021	


**A-23**

DWG NO


PROJECT NO: 21-001

CONCEPT AND DESIGN IN THIS DRAWING ARE THE PROPERTIES OF ARCHENG STUDIO PVT LTD. UNAUTHORIZED USE OR REPRODUCTION OF PART OF THE DESIGN, DRAWINGS OR CONCEPT TO USE IN OTHER PROJECTS OR SITES OTHER THAN SPECIFIED ON THIS DRAWING IS PROHIBITED






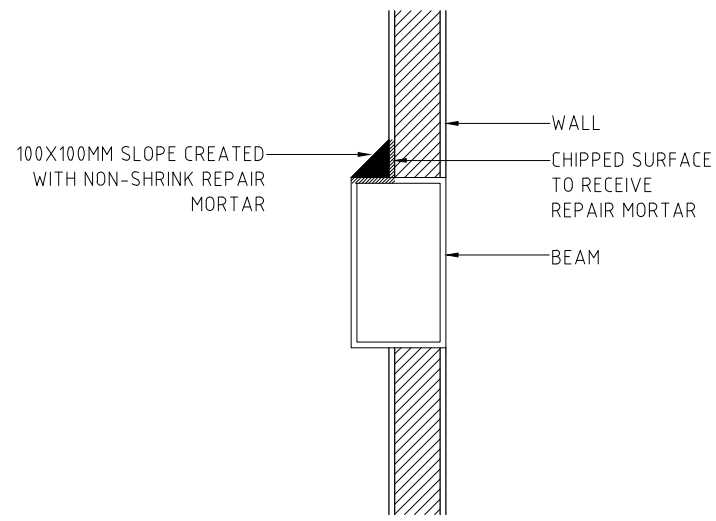

**BEAM REPAIR DETAIL**  
SCALE 1:20

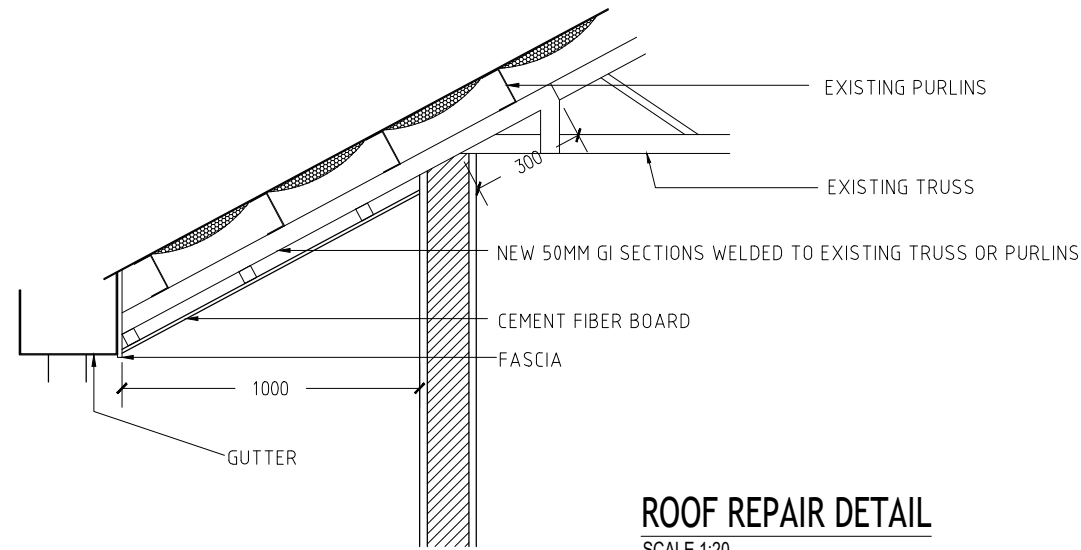

**ROOF REPAIR DETAIL**  
SCALE 1:20

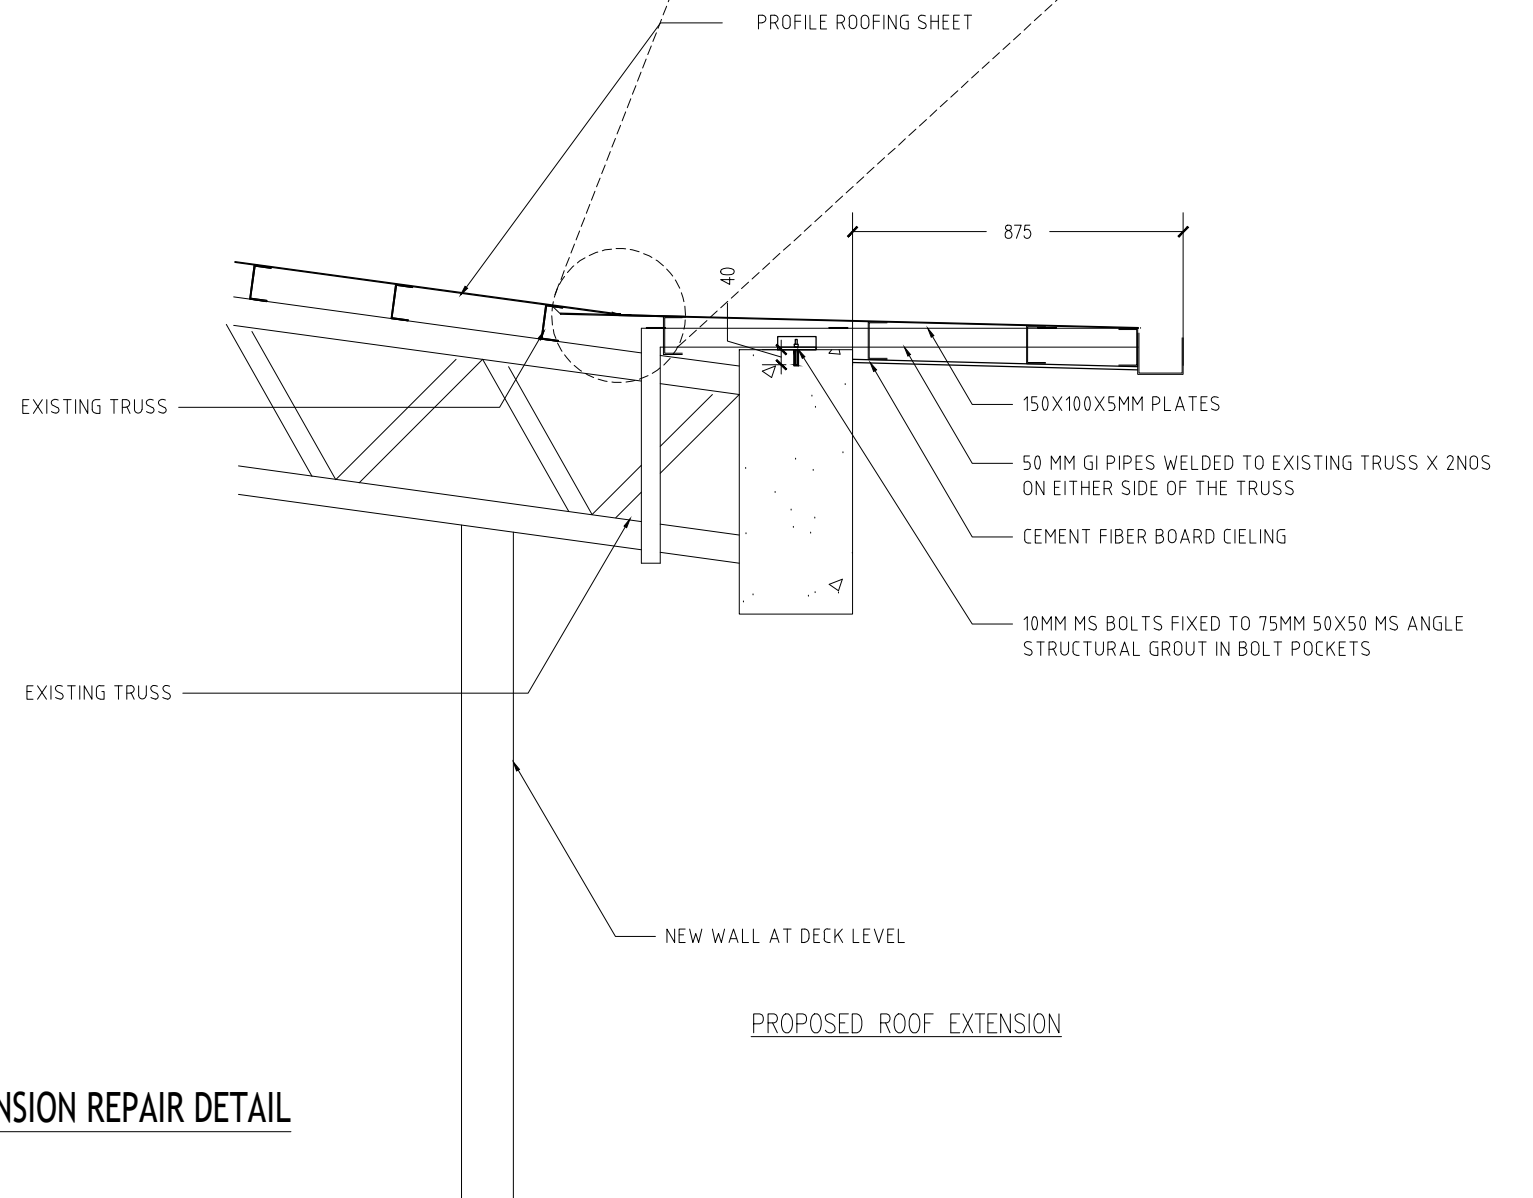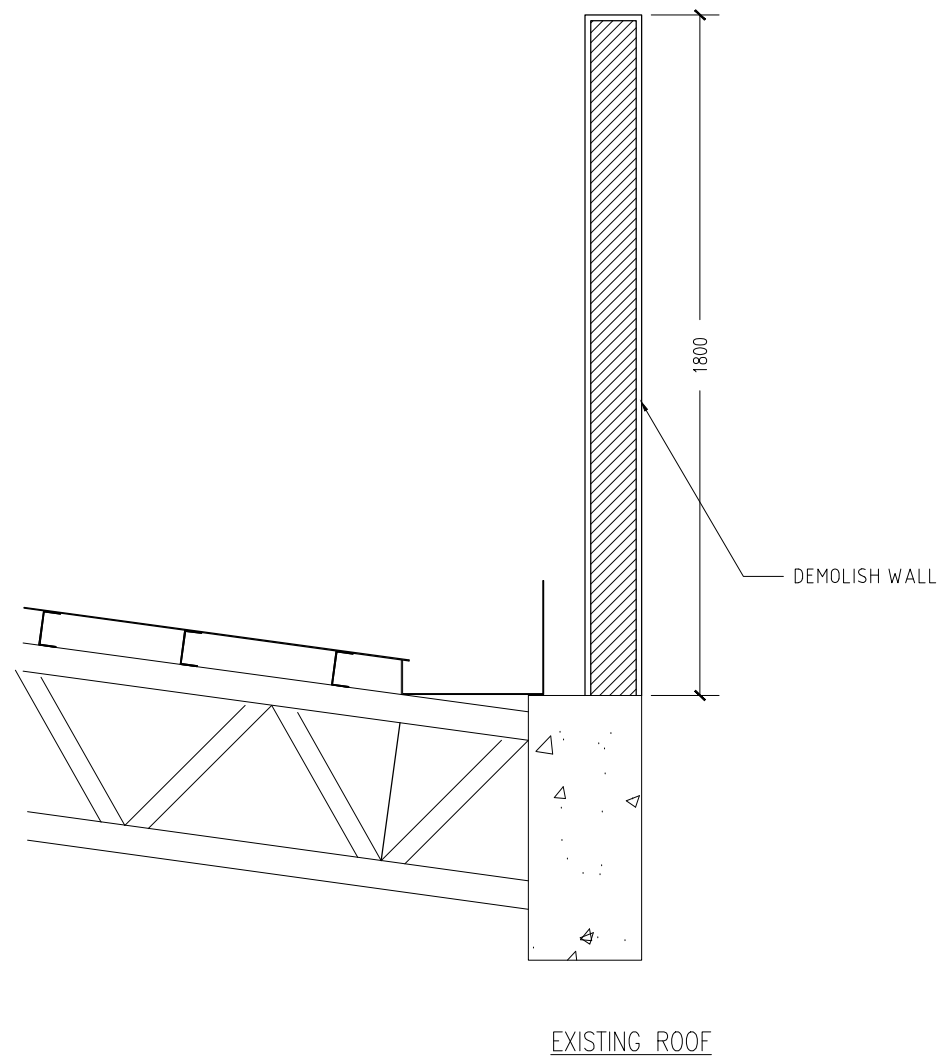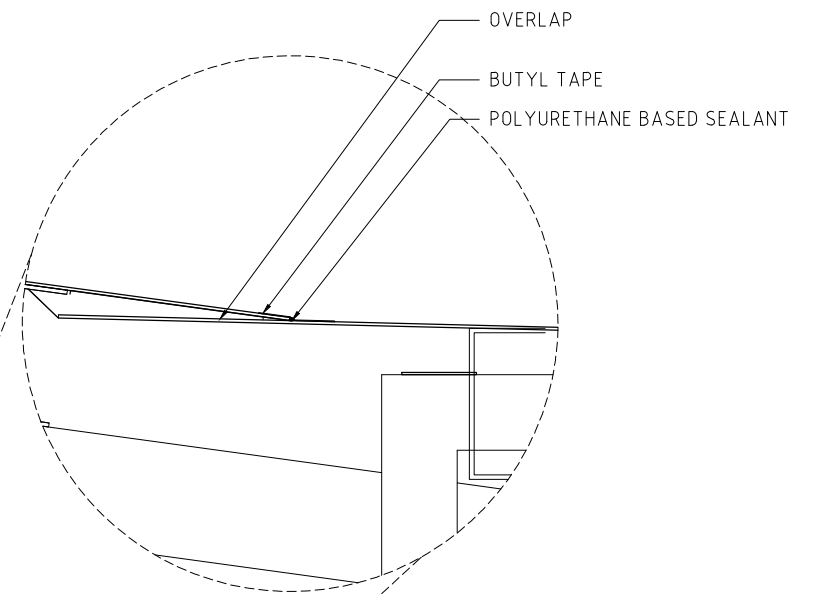

**ROOF EXTENSION REPAIR DETAIL**  
SCALE 1:20

CONTRACTORS MUST CHECK ALL DIMENSIONS ON SITE BEFORE STARTING ANY WORK OR SHOP DRAWINGS. FIGURED DIMENSIONS TO TAKE PRECEDENCE OVER SCALE READINGS




REVISION:	ARCHITECT:
	ENGINEER:
	ARCHITECTURAL CHECKER:
	STRUCTURAL CHECKER:
	DRAWN BY: AISHATH HAMRA


PROJECT:	MALDIVES POLYTECHNIC, SEENU. HITHADHOO CAMPUS
LOCATION:	SEENU. HITHADHOO
DRAWING TITLE:	AS GIVEN
CLIENT:	MINISTRY OF HIGHER EDUCATION
SCALE:	AS GIVEN
DIMENSION:	MM
DATE:	SEPTEMBER 2021

**A-24**


DWG NO  
PROJECT NO: 21-001

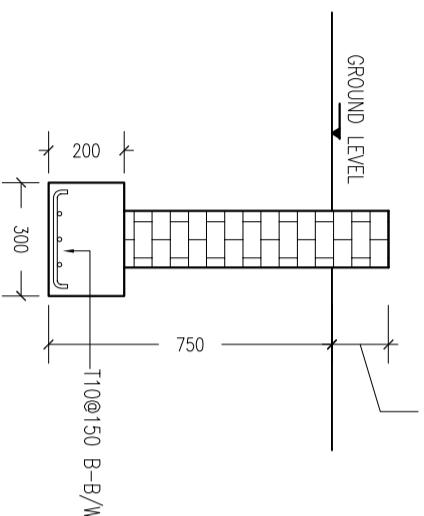


**BOUNDARY WALL FOOTING**  
SCALE 1:20

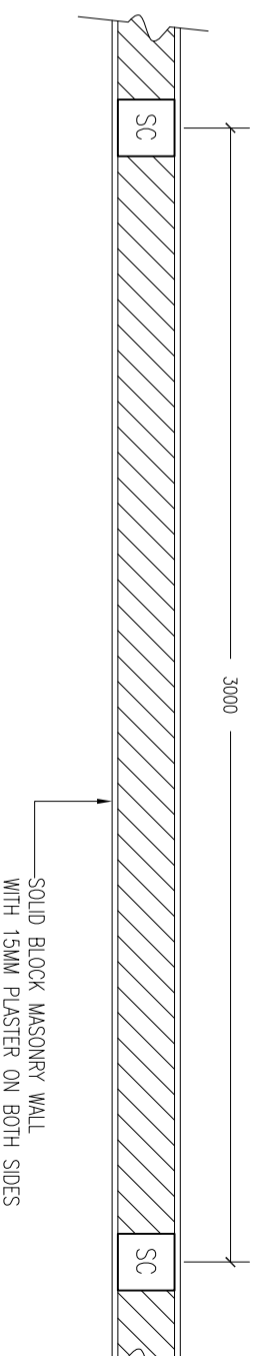


**TYPICAL BOUNDARY WALL DETAIL-PLAN**  
SCALE 1:20

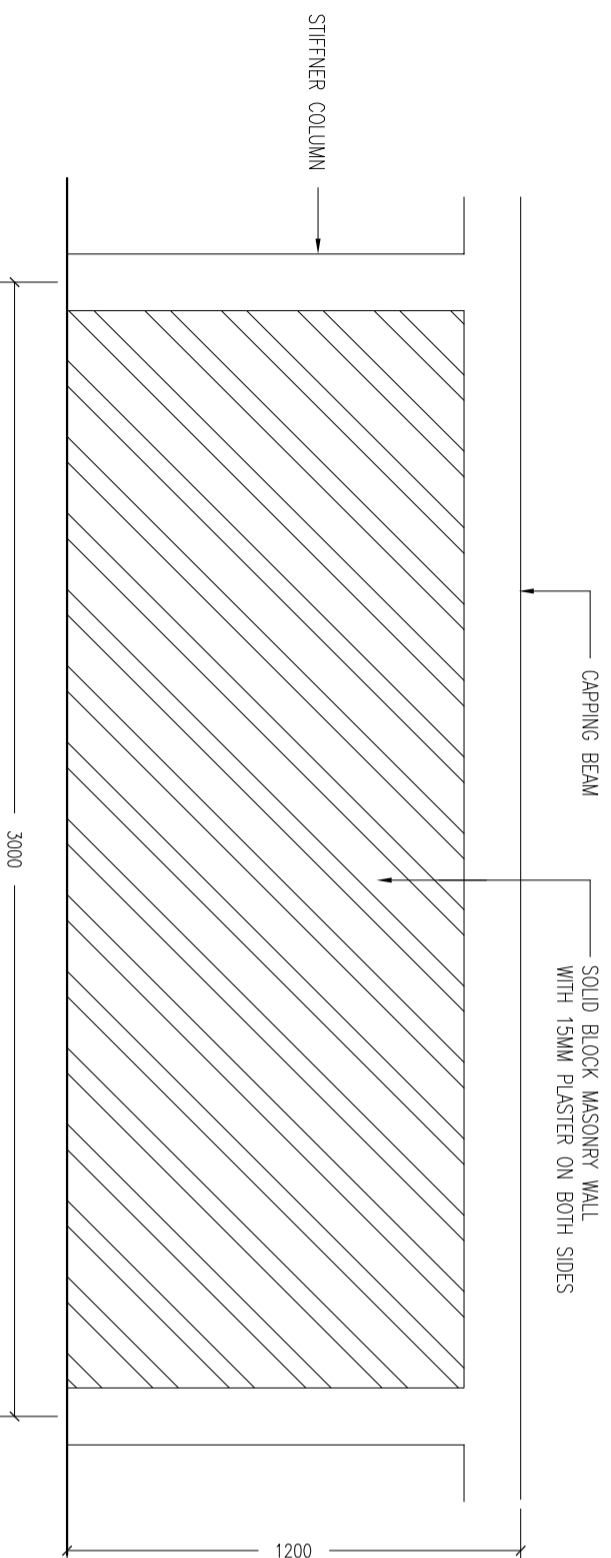

**TYPICAL BOUNDARY - WALL DETAIL ELEVATION**  
SCALE 1:20

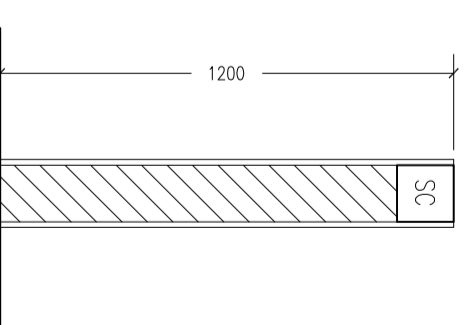

**TYPICAL BOUNDARY WALL DETAIL SECTION**  
SCALE 1:20

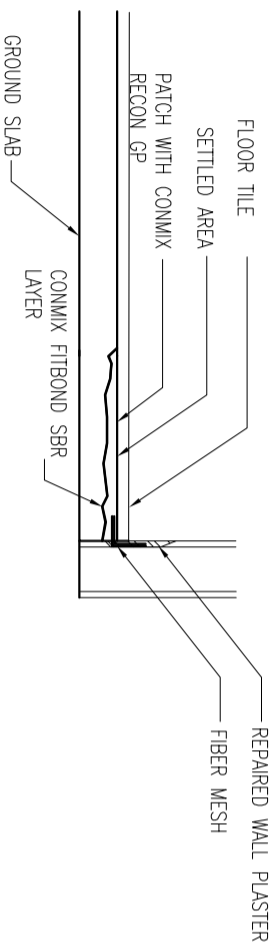

**SLAB REPAIR DETAILS**  
SCALE 1:20

CONTRACTORS MUST CHECK ALL DIMENSIONS ON SITE BEFORE STARTING ANY WORK OR SHOP DRAWINGS. FIGURED DIMENSIONS TO TAKE PRECEDENCE OVER SCALE DIMENSIONS

REVISION:	ARCHITECT:	PROJECT:	MALDIVES POLYTECHNIC, SEENU, HITHADHOO CAMPUS
	ENGINEER:	LOCATION:	SEENU, HITHADHOO
	ARCHITECTURAL CHECKER:	DRAWING TITLE:	AS GIVEN
	STRUCTURAL CHECKER:	CLIENT:	MINISTRY OF HIGHER EDUCATION
	DRAWN BY:	SCALE:	AS GIVEN
	ASHATHI HAMBA	DIMENSION:	MM
		DATE:	SEPTEMBER 2021
CONCEPT AND DESIGN IN THIS DRAWING ARE THE PROPERTIES OF ARCHENG STUDIO PVT LTD. UNAUTHORIZED USE OR REPRODUCTION OF PART OF THE DESIGN DRAWINGS OR CONCEPT TO USE IN OTHER PROJECTS OR SITES OTHER THAN SPECIFIED ON THIS DRAWING IS PROHIBITED			DWG NO
			PROJECT NO: 21-001
			<b>A-25</b>