


# SITE PLAN

SCALE: 1 : 100

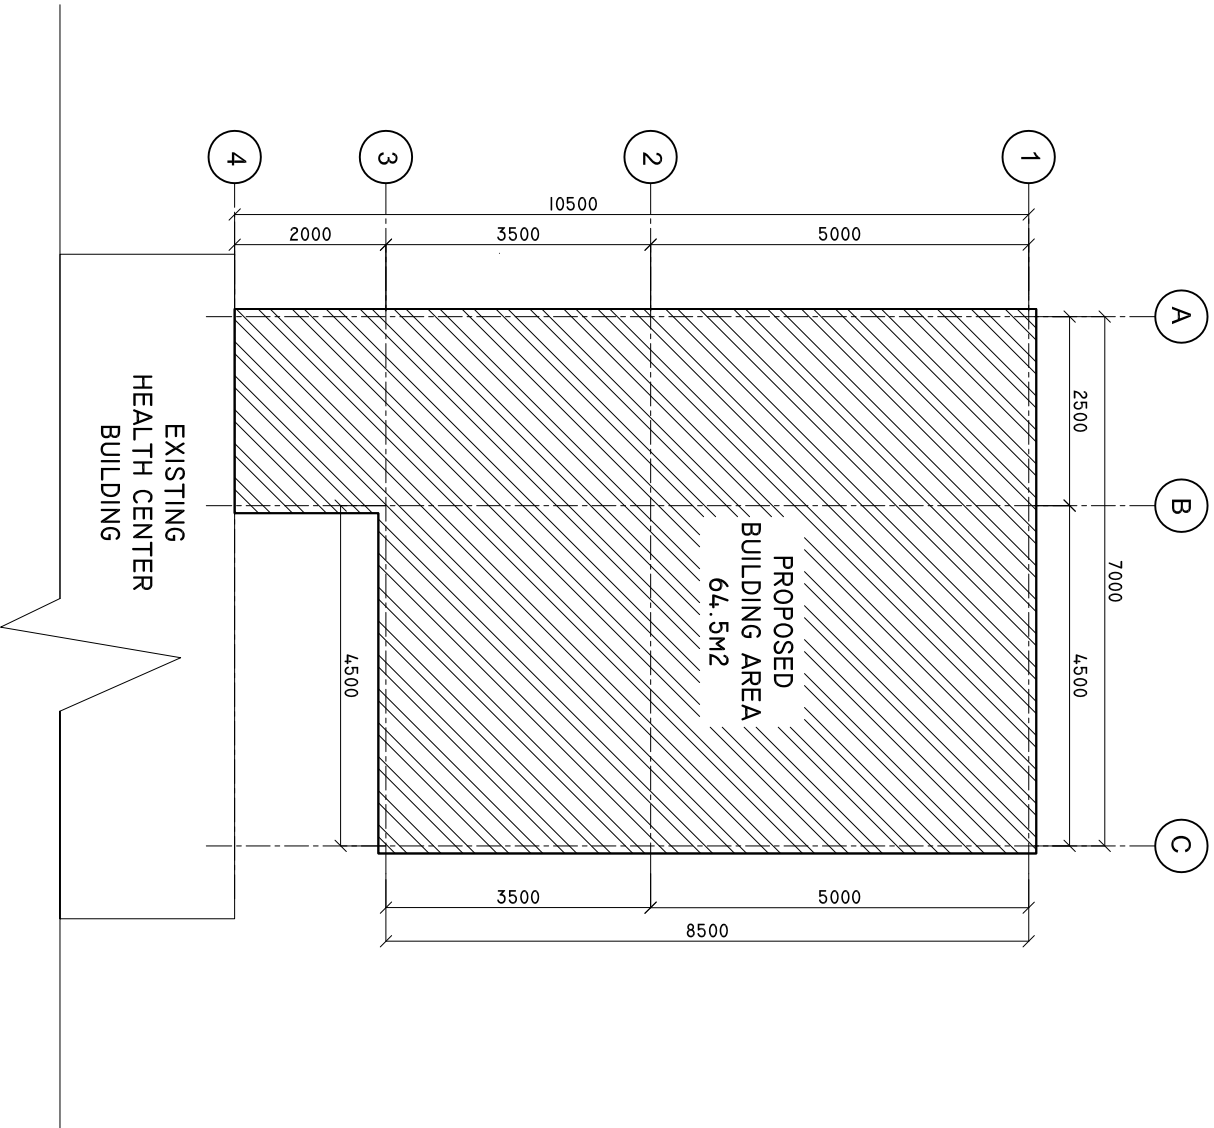

SHEET CONTENTS :

REVISION NOTES:

PROJECT:  
EXTENSION OF HA.  
THAKANDHOO HEALTH  
CENTRE

CLIENT:

MINISTRY OF HEALTH

LOCATION:

HAA ALIFU ATOLL

CONTENTS: AS GIVEN

PROJECT MANAGER:

DESIGNER: ARIZ

CIV/STR. ENGINEER:

SURVEYED BY: -

DRAWN BY: ARIZ

CHECKED BY:


DATE : OCTOBER 2012

SHEET NO. : /



# PROPOSED EXTENSION FLOOR PLAN

SCALE: 1 : 100

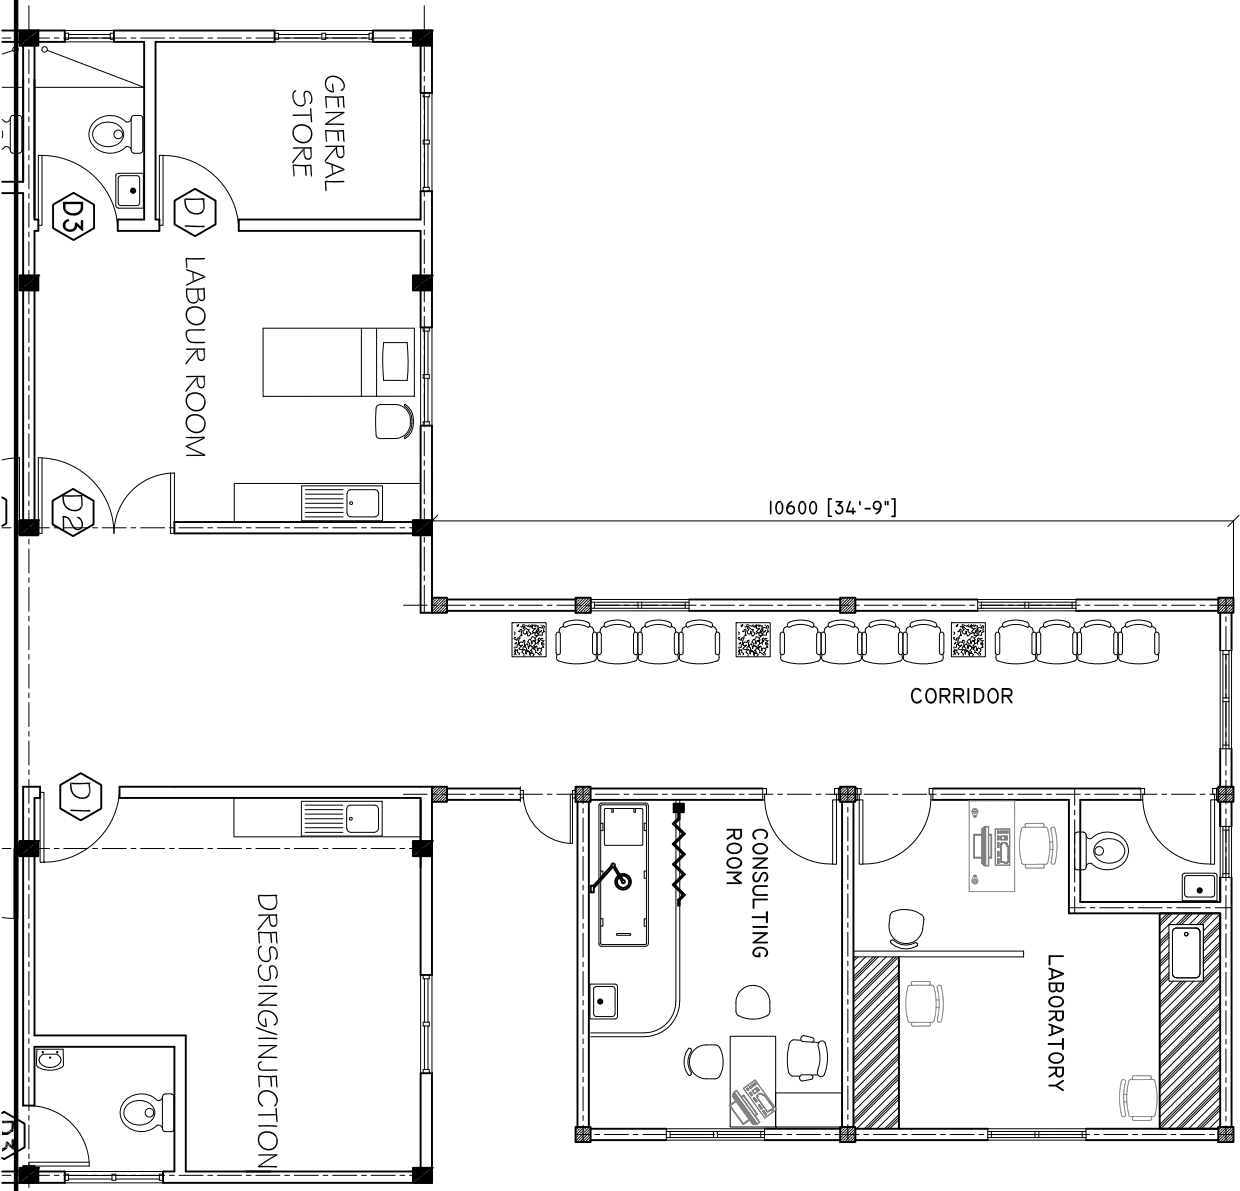

SHEET CONTENTS :

REVISION NOTES:

PROJECT:  
 EXTENSION OF HA.  
 THAKANDHOO HEALTH  
 CENTRE

CLIENT:  
 MINISTRY OF HEALTH

LOCATION:  
 HAA DHAALU ATOLL

CONTENTS: AS GIVEN


PROJECT MANAGER:  
 DESIGNER: ARIZ  
 CIV/STR. ENGINEER:  
 SURVEYED BY: -  
 DRAWN BY: ARIZ  
 CHECKED BY:  
 DATE : OCTOBER 2012  
 SHEET NO. : /



ADMIN DIVISION  
 Ministry of Health  
 Rosemead Building  
 Sosun Magu  
 Tel: 332 8887, Fax: 3328889

# FLOOR PLAN

SCALE: 1 : 100

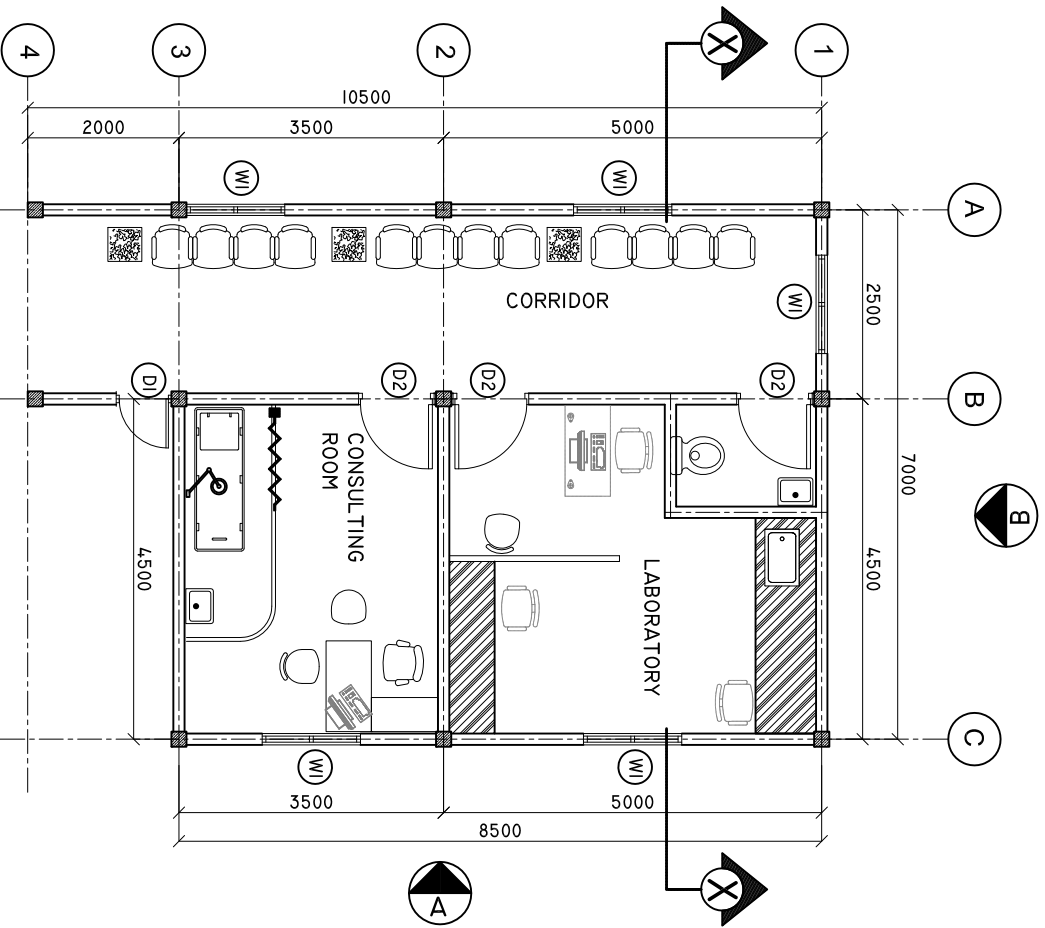

SHEET CONTENTS :

REVISION NOTES:

PROJECT:  
EXTENSION OF HA.  
THAKANDHOO HEALTH  
CENTRE

CLIENT:

MINISTRY OF HEALTH

LOCATION:

HAA ALIFU ATOLL

CONTENTS: AS GIVEN

PROJECT MANAGER:

DESIGNER: ARIZ

CIV/STR. ENGINEER:

SURVEYED BY: -

DRAWN BY: ARIZ

CHECKED BY:


DATE : OCTOBER 2012

SHEET NO. : /



# WALL DETAILS

SCALE: 1 : 100

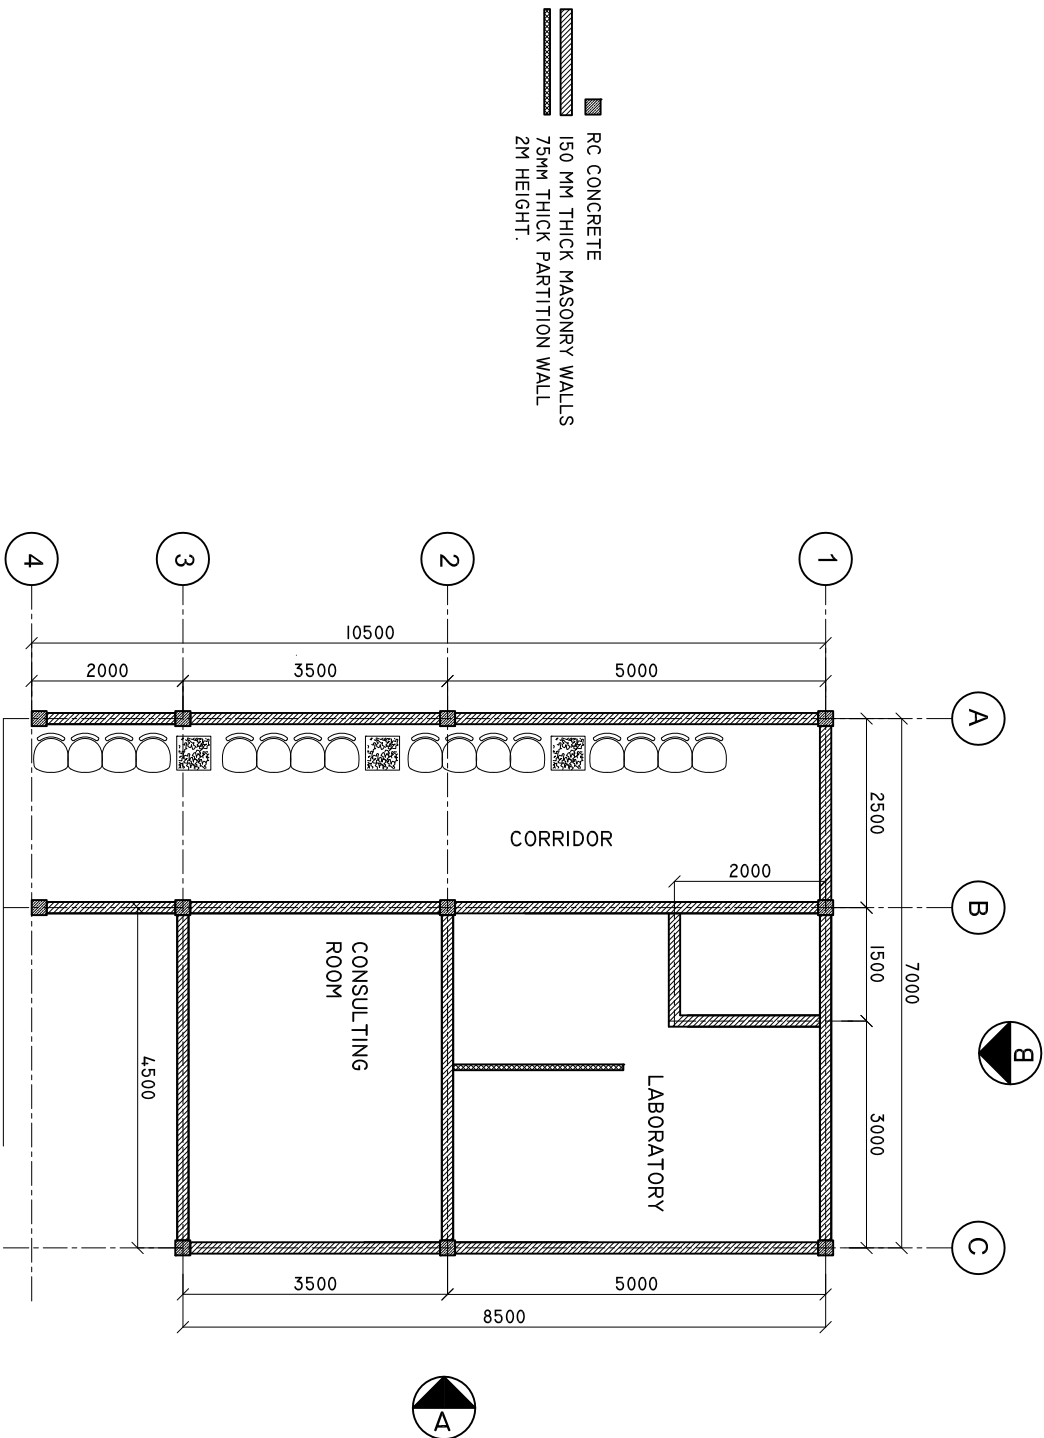

SHEET CONTENTS :

REVISION NOTES:

PROJECT:  
EXTENSION OF HA.  
THAKANDHOO HEALTH  
CENTRE

CLIENT:

MINISTRY OF HEALTH

LOCATION:

HAA ALIFU ATOLL

CONTENTS: AS GIVEN

PROJECT MANAGER:

DESIGNER: ARIZ

CIV/STR. ENGINEER:

SURVEYED BY: -

DRAWN BY: ARIZ

CHECKED BY:


DATE : OCTOBER 2012

SHEET NO. : /



# ROOF BEAM PLAN

SCALE: 1 : 100

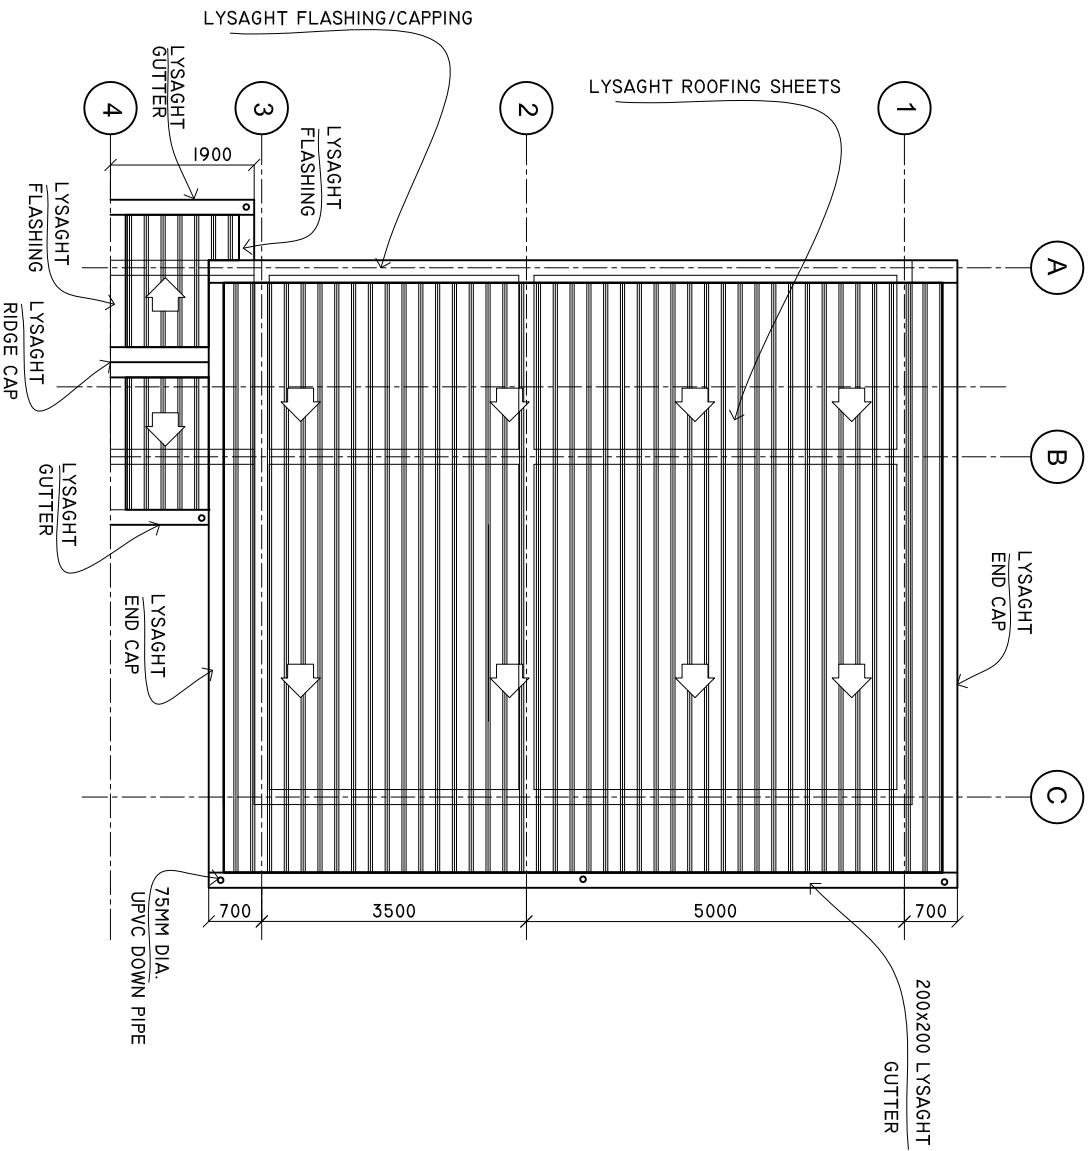

SHEET CONTENTS :

REVISION NOTES:

PROJECT:  
EXTENSION OF HA.  
THAKANDHOO HEALTH  
CENTRE

CLIENT:

MINISTRY OF HEALTH

LOCATION:

HAA ALIFU ATOLL

CONTENTS: AS GIVEN

PROJECT MANAGER:

DESIGNER: ARIZ

CIV/STR. ENGINEER:

SURVEYED BY: -

DRAWN BY: ARIZ

CHECKED BY:

DATE : OCTOBER 2012


SHEET NO. : /



ADMIN DIVISION  
Ministry of Health  
Roshanee Building  
Sosun Magu  
Tel: 332 8887 Fax: 3328889

# ROOF FRAMING PLAN

SCALE: 1 : 100

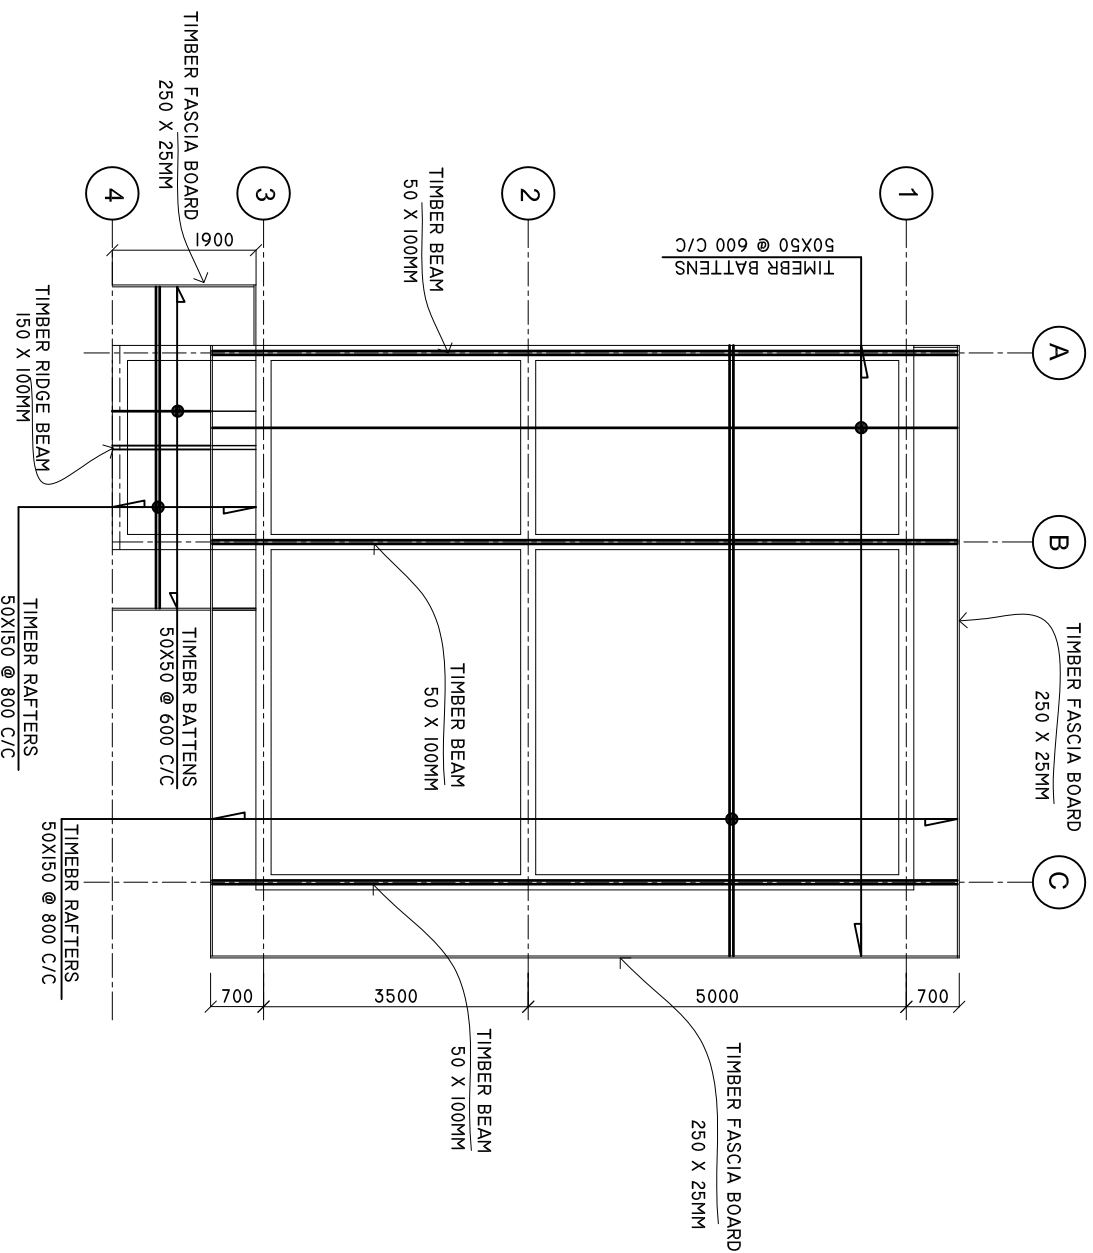

SHEET CONTENTS :

REVISION NOTES:

PROJECT:  
EXTENSION OF HA.  
THAKANDHOO HEALTH  
CENTRE

CLIENT:

MINISTRY OF HEALTH

LOCATION:

HAA ALIFU ATOLL

CONTENTS: AS GIVEN

PROJECT MANAGER:

DESIGNER: ARIZ

CIV/STR. ENGINEER:

SURVEYED BY: -

DRAWN BY: ARIZ

CHECKED BY:

DATE : OCTOBER 2012

SHEET NO. : /



ADMIN DIVISION  
Ministry of Health  
Roshanee Building  
Sosun Magu  
Tel: 332 8887 Fax: 3328889

# DOORS AND WINDOWS SCHEDULE

Scale 1:50

SYMBOL	D1	D2	W1
ELEVATION			
LOCATION	GROUND FLOOR	GROUND FLOOR	GROUND FLOOR
QUANTITY	01 NO	03 NOS	05 NOS
FRAME	SOLID TIMBER FRAME DOOR	SOLID TIMBER FRAME DOOR	ALUMINIUM FRAME DOOR
PANEL	DECORATIVE SOLID TIMBER PANEL	DECORATIVE SOLID TIMBER PANEL	ALUMINIUM 60-80 MICRON POWDER COATING
FINISH	PAINT FINISH	PAINT FINISH	ALUMINIUM 60-80 MICRON POWDER COATING
HINGE	STAINLESS STEEL	STAINLESS STEEL	STAINLESS STEEL
LOCK	STATE MAKE	STATE MAKE	STATE MAKE
NOTE	3MM THICK SS KICK PLATE & PUSH PLATE ON BOTH SIDE.	ALL MEASUREMENTS TO BE CHECKED ON SITE	ALL MEASUREMENTS TO BE CHECKED ON SITE

NOTE:

ALL MEASUREMENTS TO BE CHECKED ON SITE BEFORE FABRICATION

GL = 4MM FROSTED GLASS

SHEET CONTENTS :

REVISION NOTES:

PROJECT:  
EXTENSION OF HA.  
THAKANDHOO HEALTH  
CENTRE

CLIENT:

MINISTRY OF HEALTH

LOCATION:

HAA ALIFU ATOLL

CONTENTS: AS GIVEN

PROJECT MANAGER:

DESIGNER: ARIZ

CIV/STR. ENGINEER:

SURVEYED BY: -

DRAWN BY: ARIZ

CHECKED BY:

DATE : OCTOBER 2012


SHEET NO. : /



ADMIN DIVISION  
Ministry of Health  
Roshanee Building  
Sosun Magu  
Tel: 332 8887 Fax: 3328889

# SIDE ELEVATION "A"

SCALE: 1 : 100

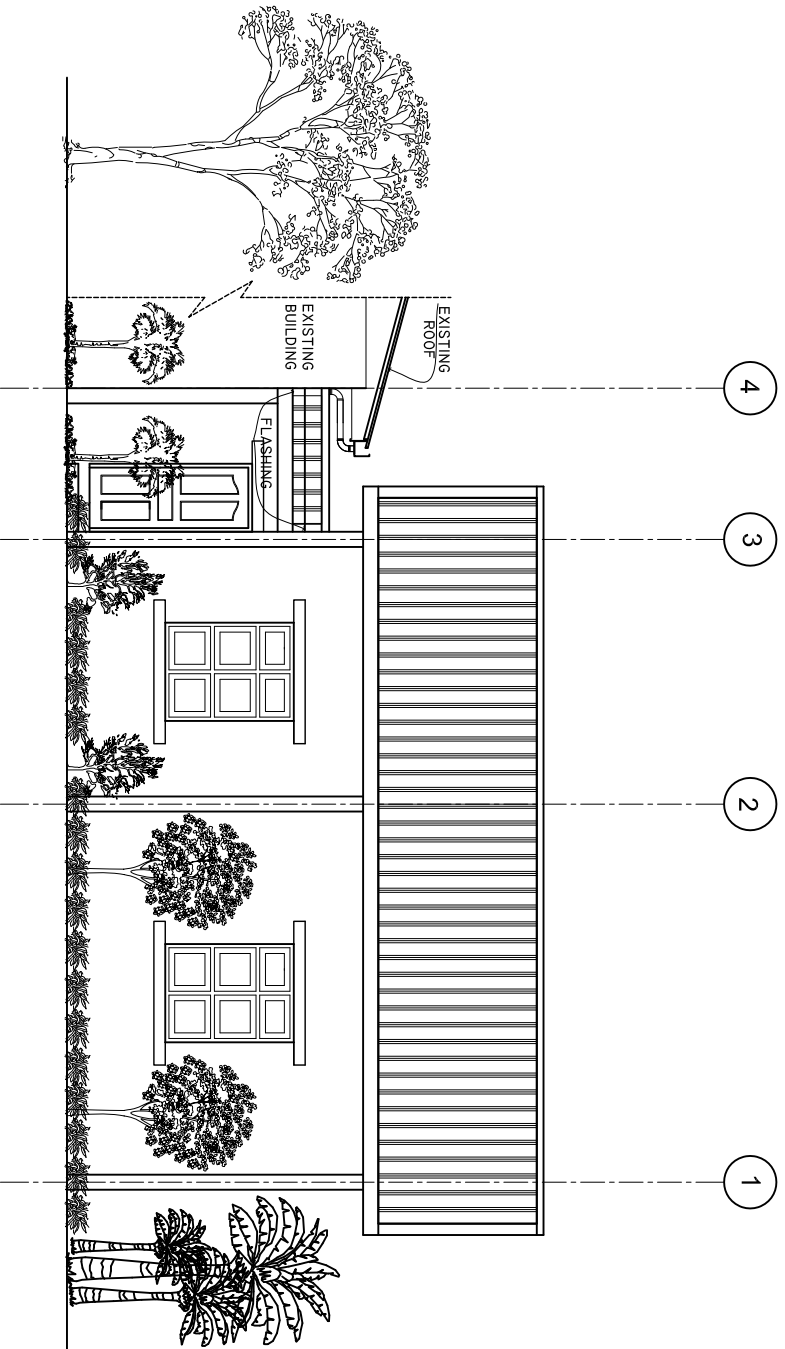

SHEET CONTENTS :

REVISION NOTES:

PROJECT:  
EXTENSION OF HA.  
THAKANDHOO HEALTH  
CENTRE

CLIENT:

MINISTRY OF HEALTH

LOCATION:

HAA ALIFU ATOLL

CONTENTS: AS GIVEN

PROJECT MANAGER:

DESIGNER: ARIZ

CIV/STR. ENGINEER:

SURVEYED BY: -

DRAWN BY: ARIZ

CHECKED BY:

DATE : OCTOBER 2012

SHEET NO. : /




ADMIN DIVISION  
Ministry of Health  
Roshanee Building  
Sosun Magu  
Tel: 332 8887 Fax: 3328889



# SIDE ELEVATION "B"

SCALE: 1 : 100

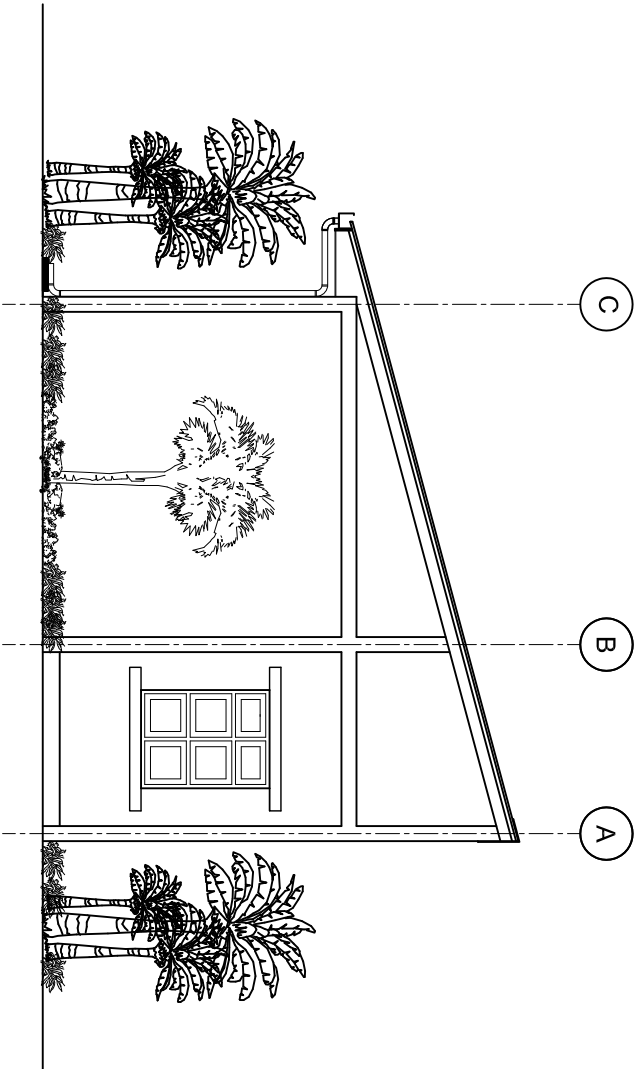

SHEET CONTENTS :

REVISION NOTES:

PROJECT:  
EXTENSION OF HA.  
THAKANDHOO HEALTH  
CENTRE

CLIENT:

MINISTRY OF HEALTH

LOCATION:

HAA ALIFU ATOLL

CONTENTS: AS GIVEN

PROJECT MANAGER:

DESIGNER: ARIZ

CIV/STR. ENGINEER:

SURVEYED BY: -

DRAWN BY: ARIZ

CHECKED BY:

DATE : OCTOBER 2012

SHEET NO. : /




ADMIN DIVISION  
Ministry of Health  
Roshanee Building  
Sosun Magu  
Tel: 332 8887 Fax: 3328889

# ELECTRICAL LAYOUT

SCALE: 1 : 100

## LEGEND

SYMBOL	DESCRIPTION
	ENERGY SAVING LIGHT (DOWN LIGHT)
	1 x 13 AMP SOCKET OUTLET (1200MM ABOVE FFL)
	2 x 13 AMP SOCKET OUTLET (1200MM ABOVE FFL)
	1 x 15 AMP SOCKET OUTLET (1200MM ABOVE FFL)
	1 x 15 AMP AC SOCKET OUTLET ( 300MM BLW, CEILING)
	TWO GANG SWITCH
	ONE WAY SWITCH
	EMERGENCY LIGHT
	DISTRIBUTION BOARD ( WALL EMBEDDED )
	AC WALL MOUNT UNIT
	TELEPHONE SOCKET
	NETWORK SOCKET
	1 x 13 AMP SOCKET OUTLET (200MM BELOW CEILING)
	FAN DIMMER
	OUT DOOR WHETHER PROOF LIGHT

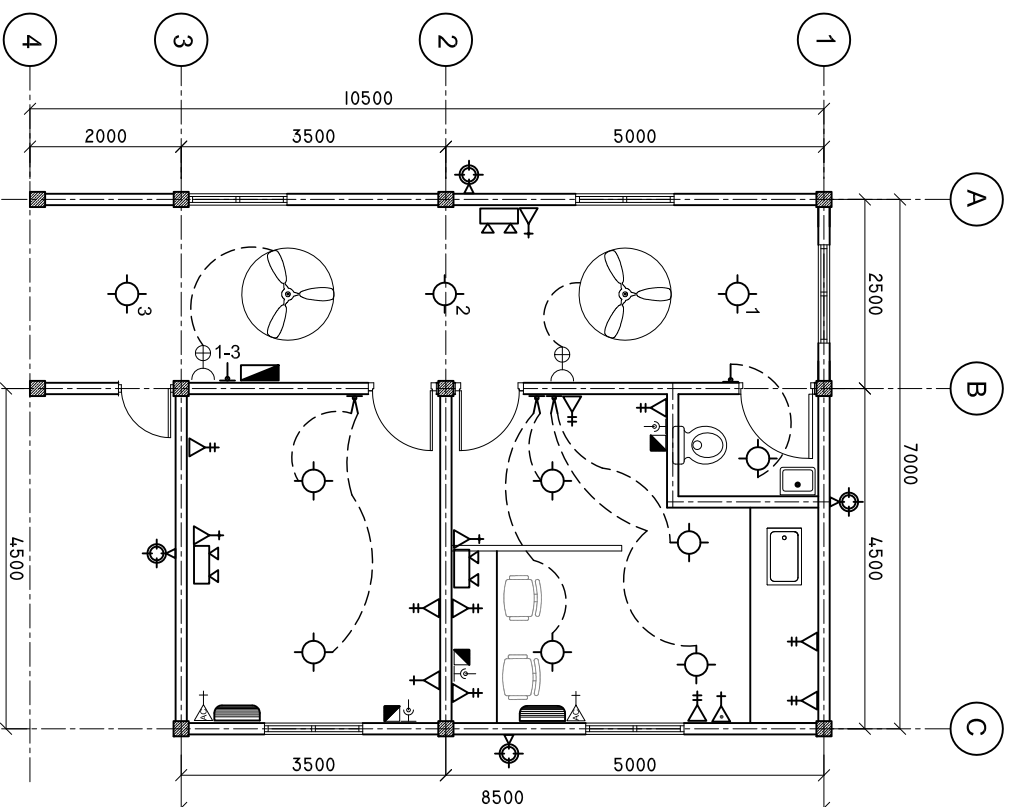

SHEET CONTENTS :

REVISION NOTES:

PROJECT:  
EXTENSION OF HA,  
THAKANDHOO HEALTH  
CENTRE

CLIENT:

MINISTRY OF HEALTH

LOCATION:

HAA ALIFU ATOLL

CONTENTS: AS GIVEN

PROJECT MANAGER:

DESIGNER: ARIZ

CIV/STR. ENGINEER:

SURVEYED BY: -

DRAWN BY: ARIZ

CHECKED BY:


DATE : OCTOBER 2012

SHEET NO. : /



# FOUNDATION PLAN

SCALE: 1 : 100

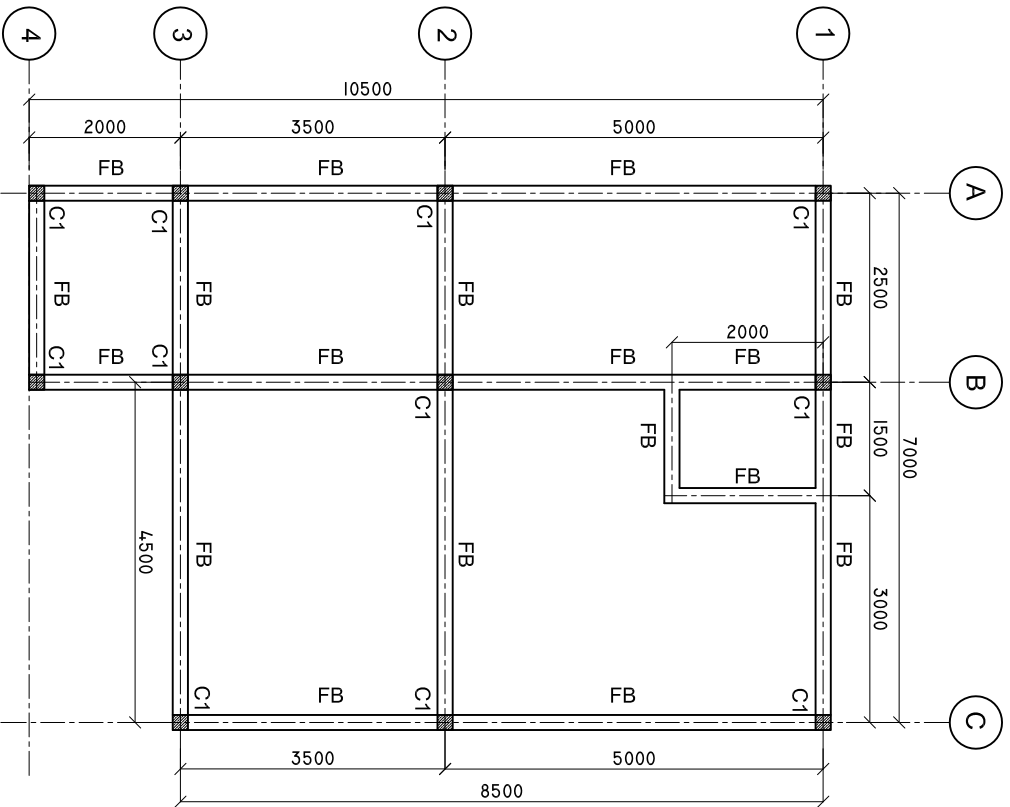

SHEET CONTENTS :

REVISION NOTES:

PROJECT:  
EXTENSION OF HA.  
THAKANDHOO HEALTH  
CENTRE

CLIENT:

MINISTRY OF HEALTH

LOCATION:

HAA ALIFU ATOLL

CONTENTS: AS GIVEN

PROJECT MANAGER:

DESIGNER: ARIZ

CIV/STR. ENGINEER:

SURVEYED BY: -

DRAWN BY: ARIZ

CHECKED BY:

DATE : OCTOBER 2012


SHEET NO. : /



ADMIN DIVISION  
Ministry of Health  
Roshanee Building  
Sosun Magu  
Tel: 332 8887 Fax: 3328889

# ROOF BEAM PLAN

SCALE: 1 : 100

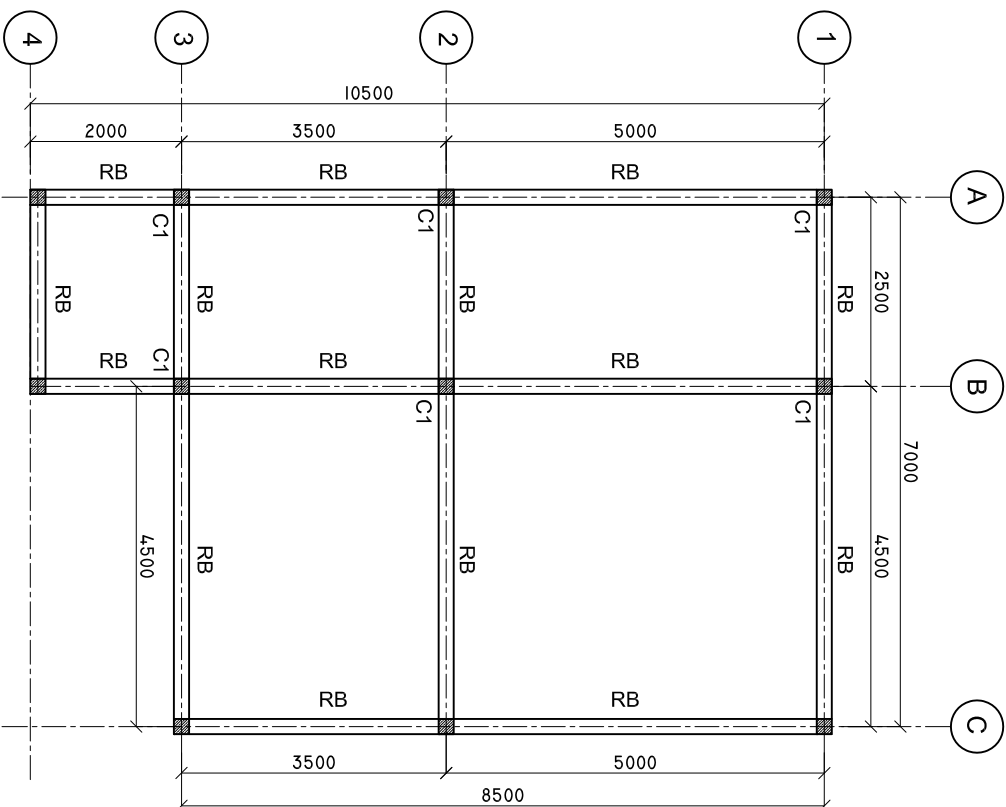

SHEET CONTENTS :

REVISION NOTES:

PROJECT:  
EXTENSION OF HA.  
THAKANDHOO HEALTH  
CENTRE

CLIENT:

MINISTRY OF HEALTH

LOCATION:

HAA ALIFU ATOLL

CONTENTS: AS GIVEN

PROJECT MANAGER:

DESIGNER: ARIZ

CIV/STR. ENGINEER:

SURVEYED BY: -

DRAWN BY: ARIZ

CHECKED BY:

DATE : OCTOBER 2012


SHEET NO. : /




ADMIN DIVISION  
Ministry of Health  
Roshanee Building  
Sosun Magu  
Tel: 332 8887 Fax: 3328889

# DETAILS R/C

 
SCALE: 1 : 25




FOUNDATION BEAM (FB)

 


COLUMN (C-1)

 

ROOF BEAM (RB)

 

LINTEL BEAM

 

SILL BEAM

MINIMUM 50MM COVER BELOW GROUND LEVEL	ALL BAR BENDING & OVERLAPS AS PER ACTUAL BS STANDARD.
MINIMUM 30MM COVER ABOVE GROUND LEVEL	

NOTE:  
LINTEL BEAMS TO BE LAID ABOVE AND BELOW ALL WINDOWS AND ALL DOORS.

SHEET CONTENTS :

REVISION NOTES:

PROJECT:  
EXTENSION OF HA.  
THAKANDHOO HEALTH  
CENTRE

CLIENT:  
MINISTRY OF HEALTH

LOCATION:  
HAA ALIFU ATOLL

CONTENTS: AS GIVEN


PROJECT MANAGER:  
DESIGNER: ARIZ  
CIV/STR. ENGINEER:  
SURVEYED BY: -  
DRAWN BY: ARIZ  
CHECKED BY:  
DATE : OCTOBER 2012  
SHEET NO. : /



ADMIN DIVISION  
Ministry of Health  
Roshanee Building  
Sosun Magu  
Tel: 332 8887 Fax: 3328889

# CROSS SECTION X-X

SCALE: 1 : 50

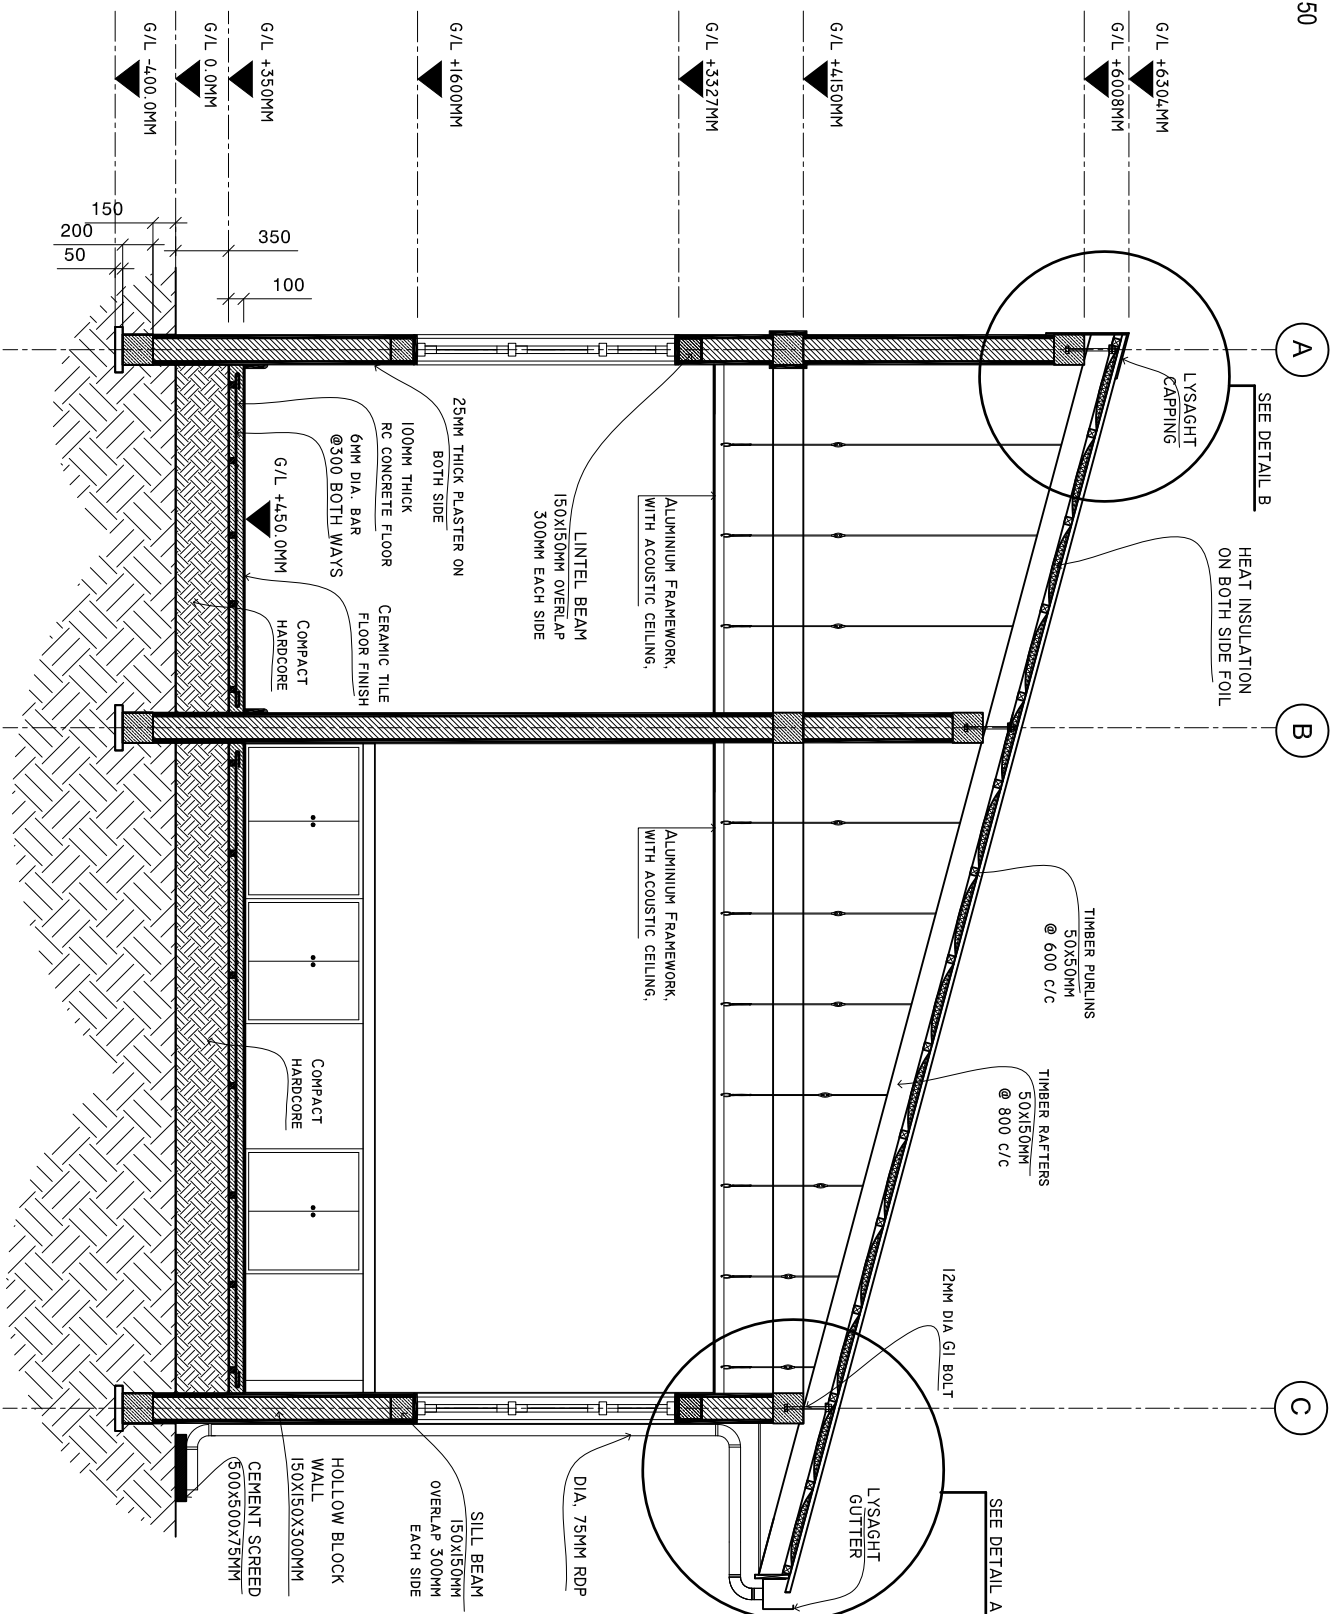

SHEET CONTENTS :

REVISION NOTES:

PROJECT:  
 EXTENSION OF HA.  
 THAKANDHOO HEALTH  
 CENTRE

CLIENT:

MINISTRY OF HEALTH

LOCATION:

HAA ALIFU ATOLL

CONTENTS: AS GIVEN

PROJECT MANAGER:

DESIGNER: ARIZ

CIV/STR. ENGINEER:

SURVEYED BY: -

DRAWN BY: ARIZ

CHECKED BY:


DATE : OCTOBER 2012

SHEET NO. : /



# DETAIL A

SCALE: 1 : 10

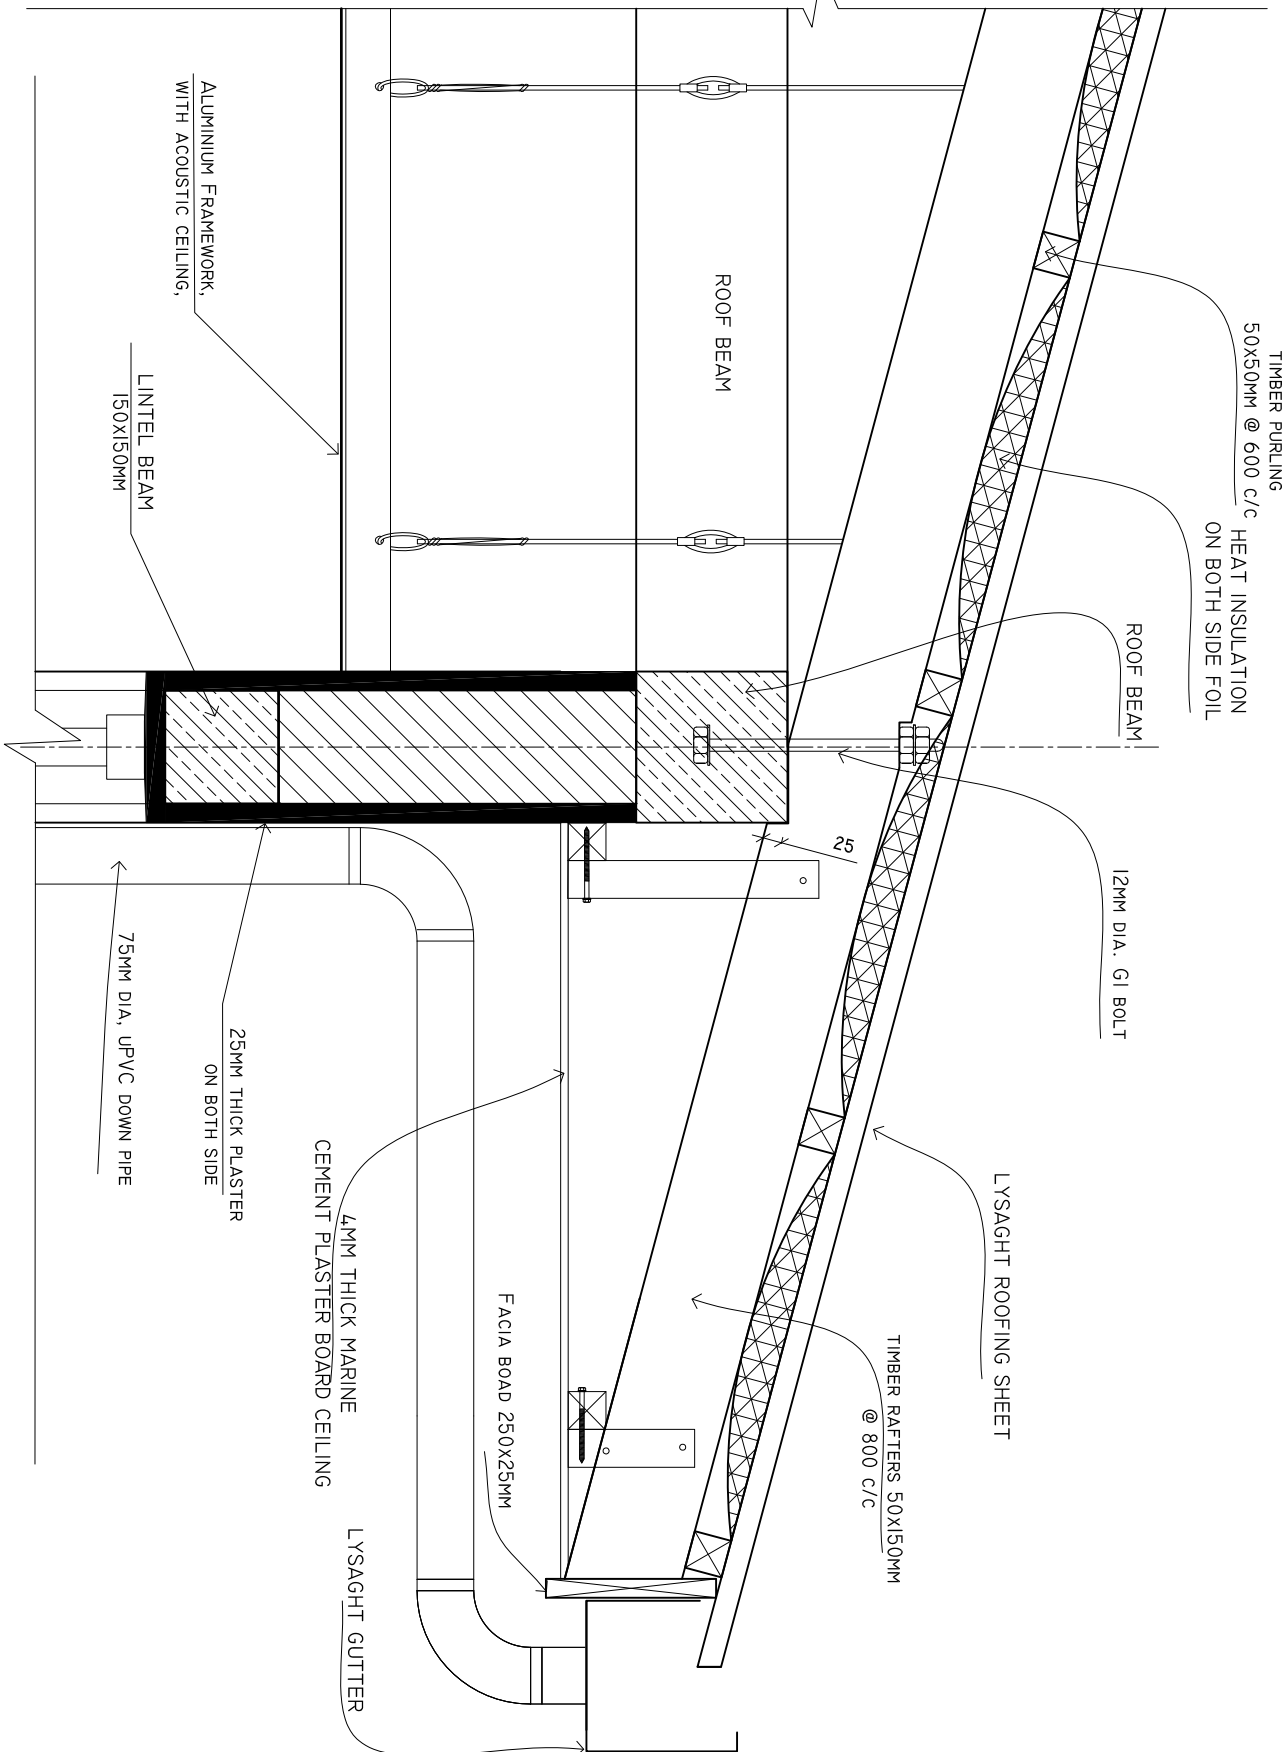

SHEET CONTENTS :

REVISION NOTES:

PROJECT:  
EXTENSION OF HA.  
THAKANDHOO HEALTH  
CENTRE

CLIENT:

MINISTRY OF HEALTH

LOCATION:

HAA ALIFU ATOLL

CONTENTS: AS GIVEN

PROJECT MANAGER:

DESIGNER: ARIZ

CIV/STR. ENGINEER:

SURVEYED BY: -

DRAWN BY: ARIZ

CHECKED BY:


DATE : OCTOBER 2012

SHEET NO. : /



# DETAIL B

SCALE: 1 : 10

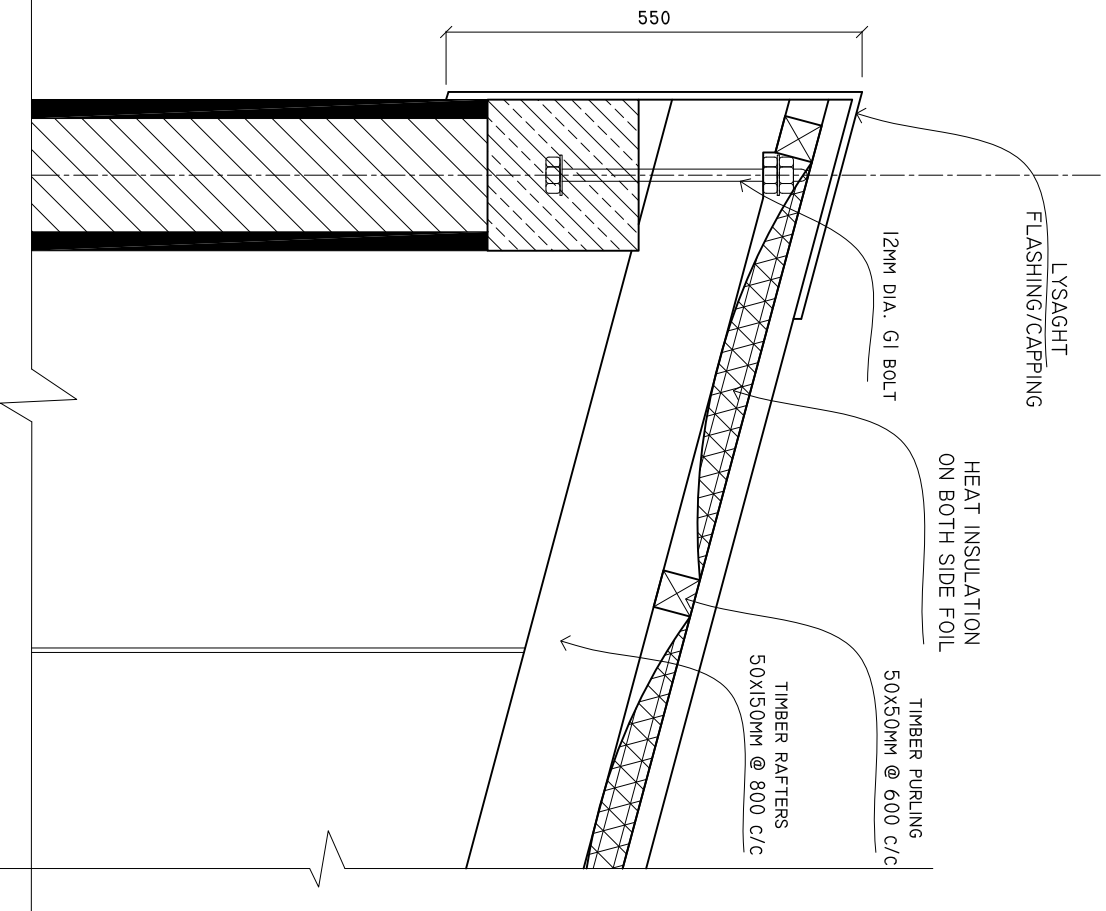

SHEET CONTENTS :

REVISION NOTES:

PROJECT:  
EXTENSION OF HA.  
THAKANDHOO HEALTH  
CENTRE

CLIENT:

MINISTRY OF HEALTH

LOCATION:

HAA ALIFU ATOLL

CONTENTS: AS GIVEN

PROJECT MANAGER:

DESIGNER: ARIZ

CIV/STR. ENGINEER:

SURVEYED BY: -

DRAWN BY: ARIZ

CHECKED BY:

DATE : OCTOBER 2012

SHEET NO. : /




ADMIN DIVISION  
Ministry of Health  
Roshanee Building  
Sosun Magu  
Tel: 332 8887 Fax: 3328889



# LAB SINK CUPBOARD FRONT ELEVATION


**SCALE: 1 : 20**

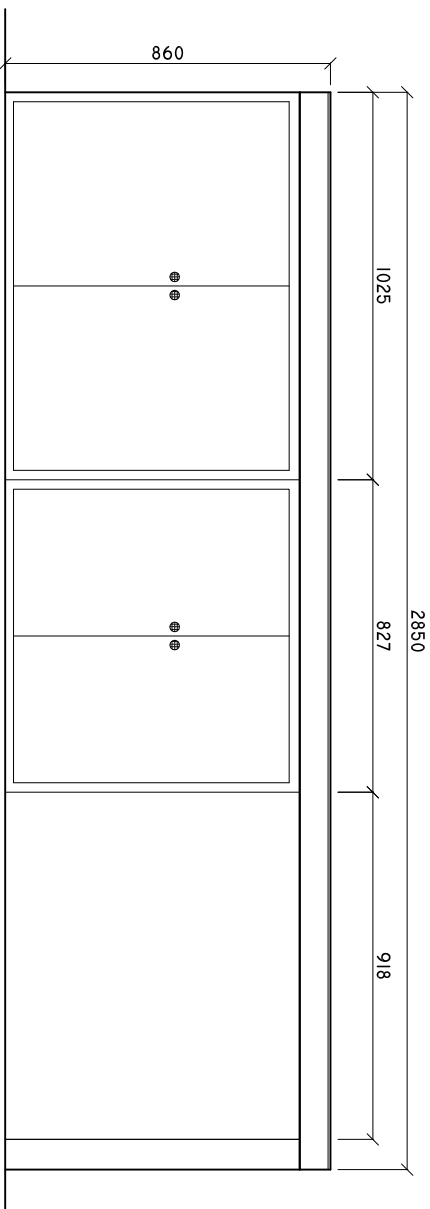

# LAB ROOM SINK CUPBOARD

## PLAN

**SCALE: 1 : 20**

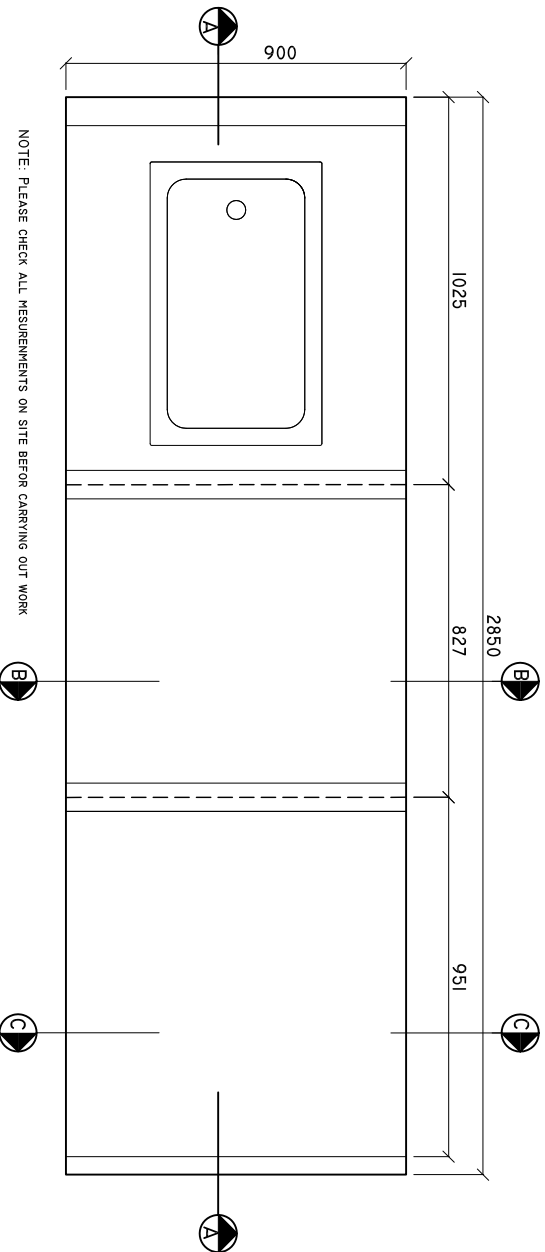

NOTE: PLEASE CHECK ALL MEASUREMENTS ON SITE BEFORE CARRYING OUT WORK

SHEET CONTENTS :

REVISION NOTES:

**PROJECT:**  
EXTENSION OF HA.  
THAKANDHOO HEALTH  
CENTRE

**CLIENT:**

**MINISTRY OF HEALTH**

**LOCATION:**

**HAA ALIFU ATOLL**


**CONTENTS:** AS GIVEN

**PROJECT MANAGER:**  
**DESIGNER:** ARIZ  
**CIV/STR. ENGINEER:**  
**SURVEYED BY:** -  
**DRAWN BY:** ARIZ  
**CHECKED BY:**  
**DATE :** OCTOBER 2012  
**SHEET NO. :** /



**ADMIN DIVISION**  
Ministry of Health  
Roshanee Building  
Sosun Magu  
Tel: 332 8887 Fax: 3328889

# LAB CUPBOARD SECTION A-A SCALE: 1 : 20

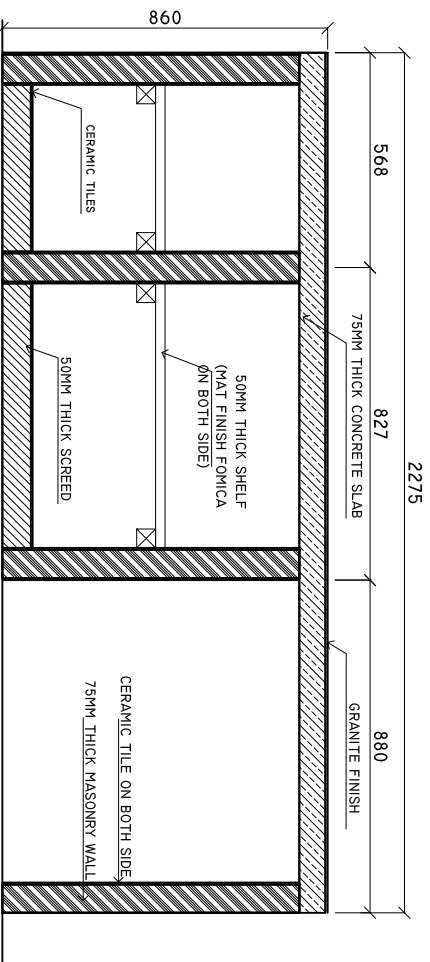

NOTE: PLEASE CHECK ALL MEASUREMENTS ON SITE BEFORE CARRYING OUT WORK

SHEET CONTENTS :

REVISION NOTES:

PROJECT:  
EXTENSION OF HA,  
THAKANDHOO HEALTH  
CENTRE

CLIENT:

MINISTRY OF HEALTH

LOCATION:

HAA ALIFU ATOLL

CONTENTS: AS GIVEN

PROJECT MANAGER:

DESIGNER: ARIZ

CIV/STR. ENGINEER:

SURVEYED BY: -

DRAWN BY: ARIZ

CHECKED BY:


DATE : OCTOBER 2012

SHEET NO. : /



ADMIN DIVISION  
Ministry of Health  
Rossmore Building  
Sosun Magu  
Tel: 332 8887, Fax: 3328889

**LAB SINK CUPBOARD  
DETAIL C-C**  
SCALE: 1 : 10

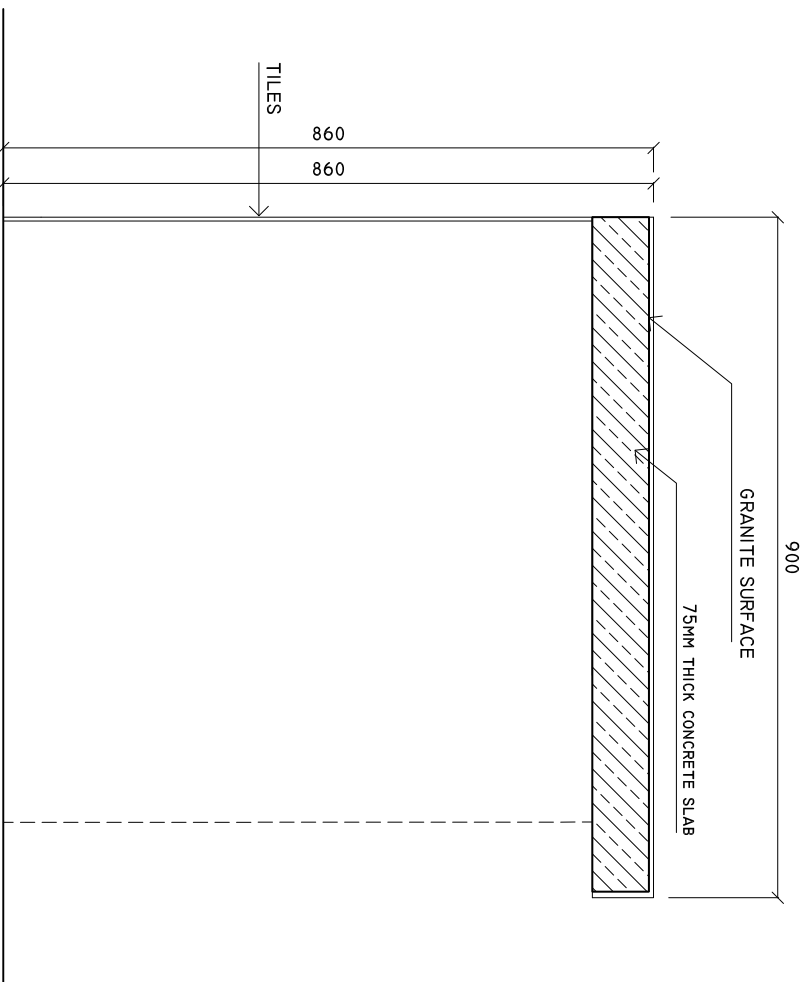

SHEET CONTENTS :

REVISION NOTES:

PROJECT:  
EXTENSION OF HA.  
THAKANDHOO HEALTH  
CENTRE

CLIENT:

MINISTRY OF HEALTH

LOCATION:

HAA ALIFU ATOLL

CONTENTS: AS GIVEN

PROJECT MANAGER:

DESIGNER: ARIZ

CIV/STR. ENGINEER:

SURVEYED BY: -

DRAWN BY: ARIZ


CHECKED BY:

DATE : OCTOBER 2012

SHEET NO. : /



**LAB SINK CUPBOARD  
DETAIL B-B**  
SCALE: 1 : 10

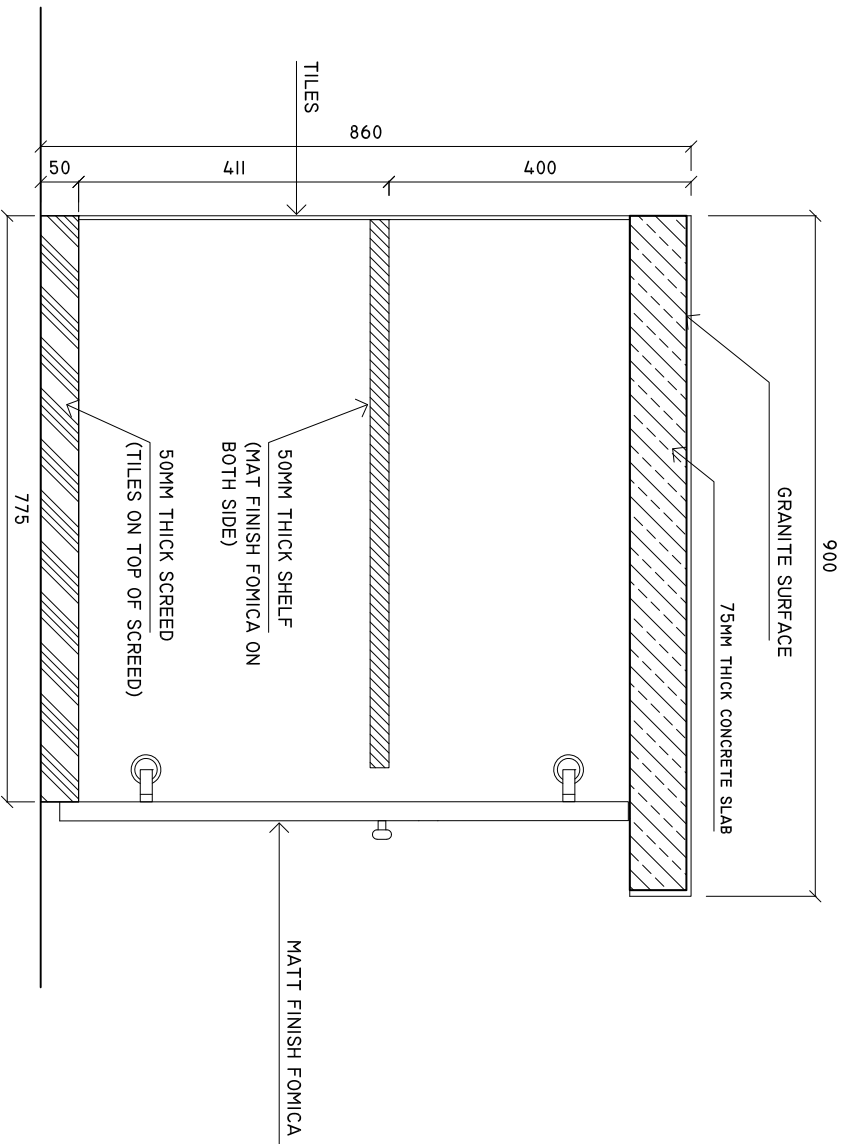

NOTE: PLEASE CHECK ALL MESUREMENTS ON SITE BEFORE CARRYING OUT WORK

SHEET CONTENTS :

REVISION NOTES:

PROJECT:  
EXTENSION OF HA.  
THAKANDHOO HEALTH  
CENTRE

CLIENT:

MINISTRY OF HEALTH

LOCATION:

HAA ALIFU ATOLL

CONTENTS: AS GIVEN

PROJECT MANAGER:

DESIGNER: ARIZ

CIV/STR. ENGINEER:

SURVEYED BY: -

DRAWN BY: ARIZ

CHECKED BY:

DATE : OCTOBER 2012


SHEET NO. : /



ADMIN DIVISION  
Ministry of Health  
Rosemead Building  
Sosun Magu  
Tel: 332 8887, Fax: 3328889


## LAB CUPBOARD FRONT ELEVATION

**SCALE: 1 : 20**

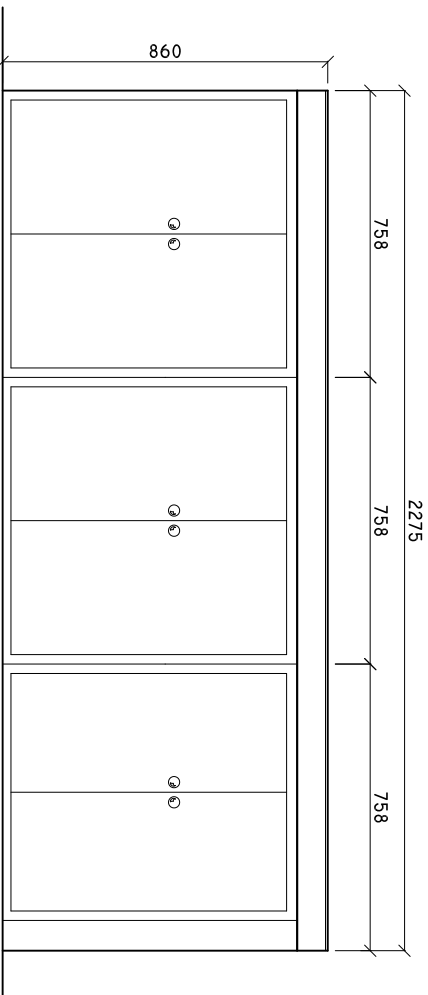

## LAB ROOM SINK CUPBOARD PLAN

**SCALE: 1 : 20**

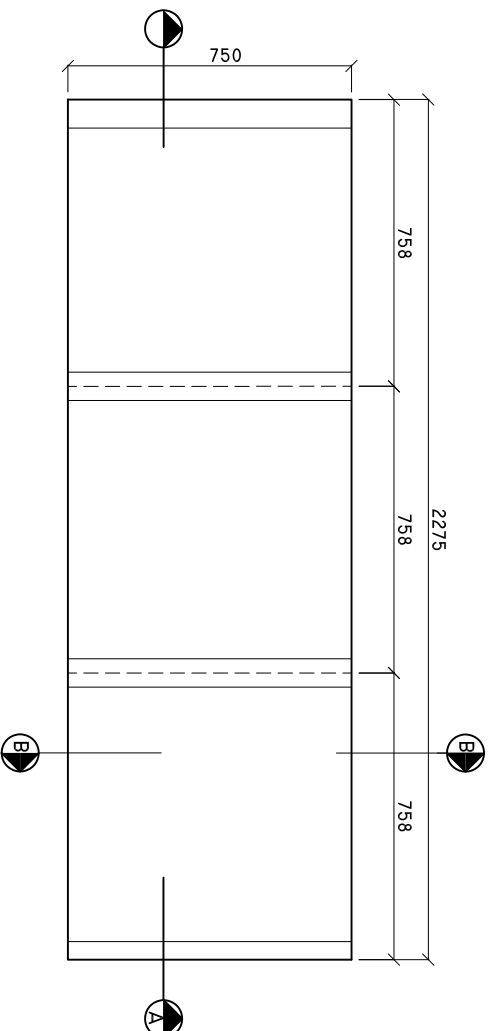

NOTE: PLEASE CHECK ALL MEASUREMENTS ON SITE BEFORE CARRYING OUT WORK

SHEET CONTENTS :

REVISION NOTES:

PROJECT:  
EXTENSION OF HA.  
THAKANDHOO HEALTH  
CENTRE

CLIENT:

MINISTRY OF HEALTH

LOCATION:

HAA ALIFU ATOLL

CONTENTS: AS GIVEN

PROJECT MANAGER:

DESIGNER: ARIZ

CIV/STR. ENGINEER:

SURVEYED BY: -

DRAWN BY: ARIZ

CHECKED BY:


DATE : OCTOBER 2012

SHEET NO. : /



ADMIN DIVISION  
Ministry of Health  
Roslanee Building  
Sosun Magu  
Tel: 332 8887, Fax: 3328889

**LAB SINK CUPBOARD**  
**SECTION A-A**  
**SCALE: 1 : 20**

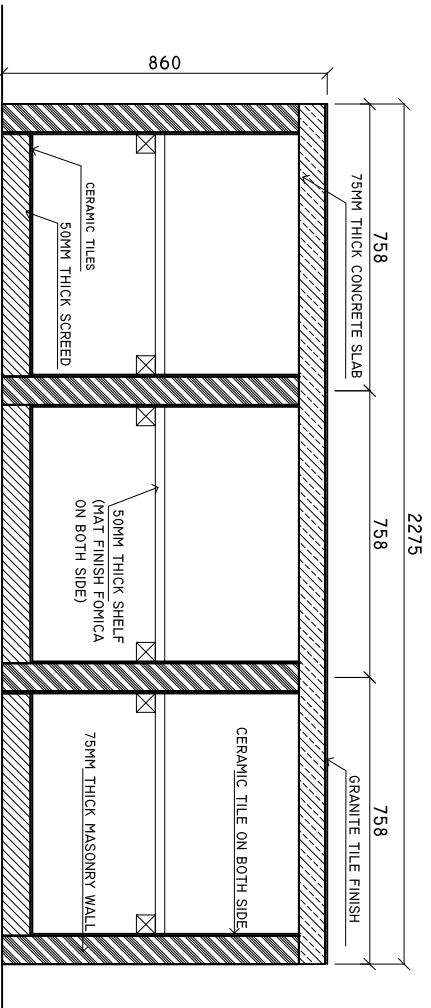

NOTE: PLEASE CHECK ALL MEASUREMENTS ON SITE BEFORE CARRYING OUT WORK

SHEET CONTENTS :

REVISION NOTES:

PROJECT:  
 EXTENSION OF HA.  
 THAKANDHOO HEALTH  
 CENTRE

CLIENT:

MINISTRY OF HEALTH

LOCATION:

HAA ALIFU ATOLL

CONTENTS: AS GIVEN

PROJECT MANAGER:

DESIGNER: ARIZ

CIV/STR. ENGINEER:

SURVEYED BY: -

DRAWN BY: ARIZ


CHECKED BY:

DATE : OCTOBER 2012

SHEET NO. : /



**LAB SINK CUPBOARD  
DETAIL B-B**  
SCALE: 1 : 10

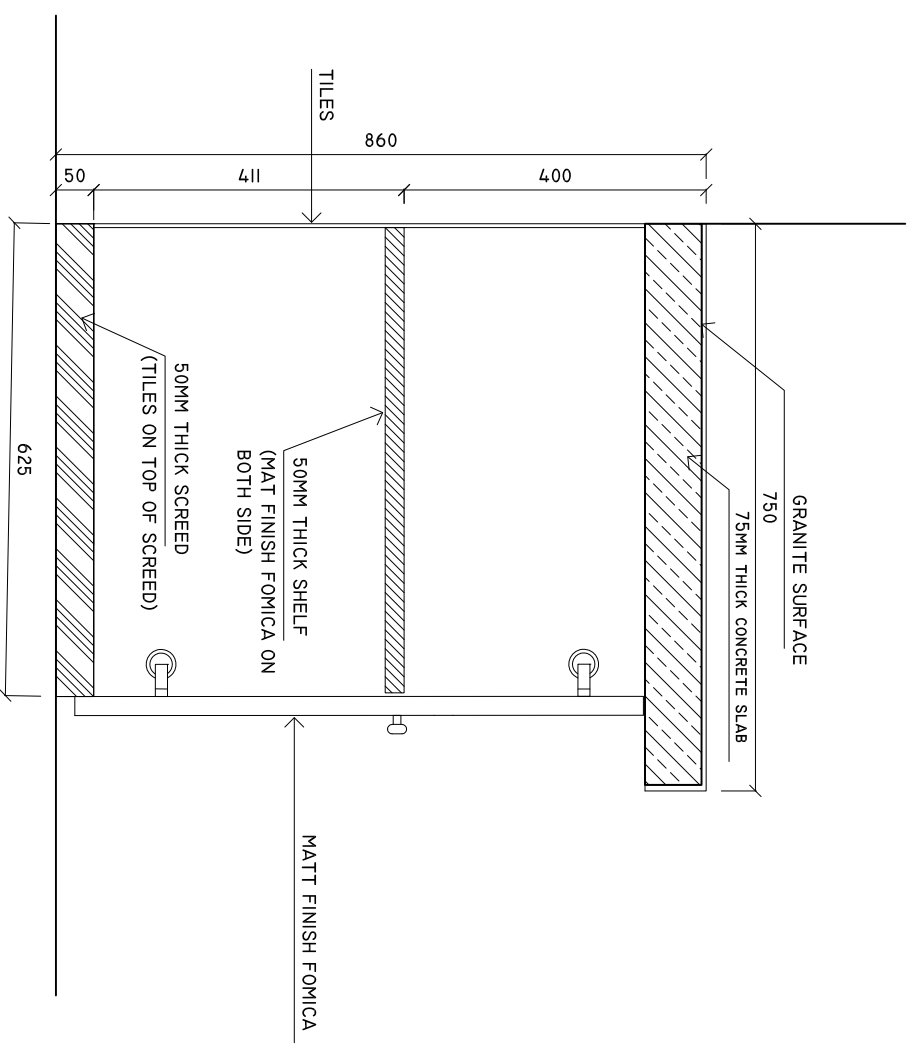

NOTE : PLEASE CHECK ALL MESUREMENTS ON SITE BEFOR  
CARRYING OUT WORK

SHEET CONTENTS :

REVISION NOTES:

PROJECT:  
EXTENSION OF HA.  
THAKANDHOO HEALTH  
CENTRE

CLIENT:

MINISTRY OF HEALTH

LOCATION:  
HAA ALIFU ATOLL

CONTENTS: AS GIVEN

PROJECT MANAGER:  
DESIGNER: ARIZ  
CIV/STR. ENGINEER:  
SURVEYED BY: -  
DRAWN BY: ARIZ  
CHECKED BY:  
DATE : OCTOBER 2012  
SHEET NO. : /



ADMIN DIVISION  
Ministry of Health  
Roshanee Building  
Sosun Magu  
Tel: 332 8887, Fax: 3328889