

Project Title:  
OUTSTATION CALL CENTER

Dwg title:  
FLOOR PLAN

Location:  
FVM MEDIA CENTER

Department:  
FACILITIES MANAGEMENT SERVICES


Design & Drawn:  
M.SHIFAU

Date:  
May 24, 2022

Scale:  
---

Page No: 1  
Rev No: ---

FACILITIES AND MAINTENANCE

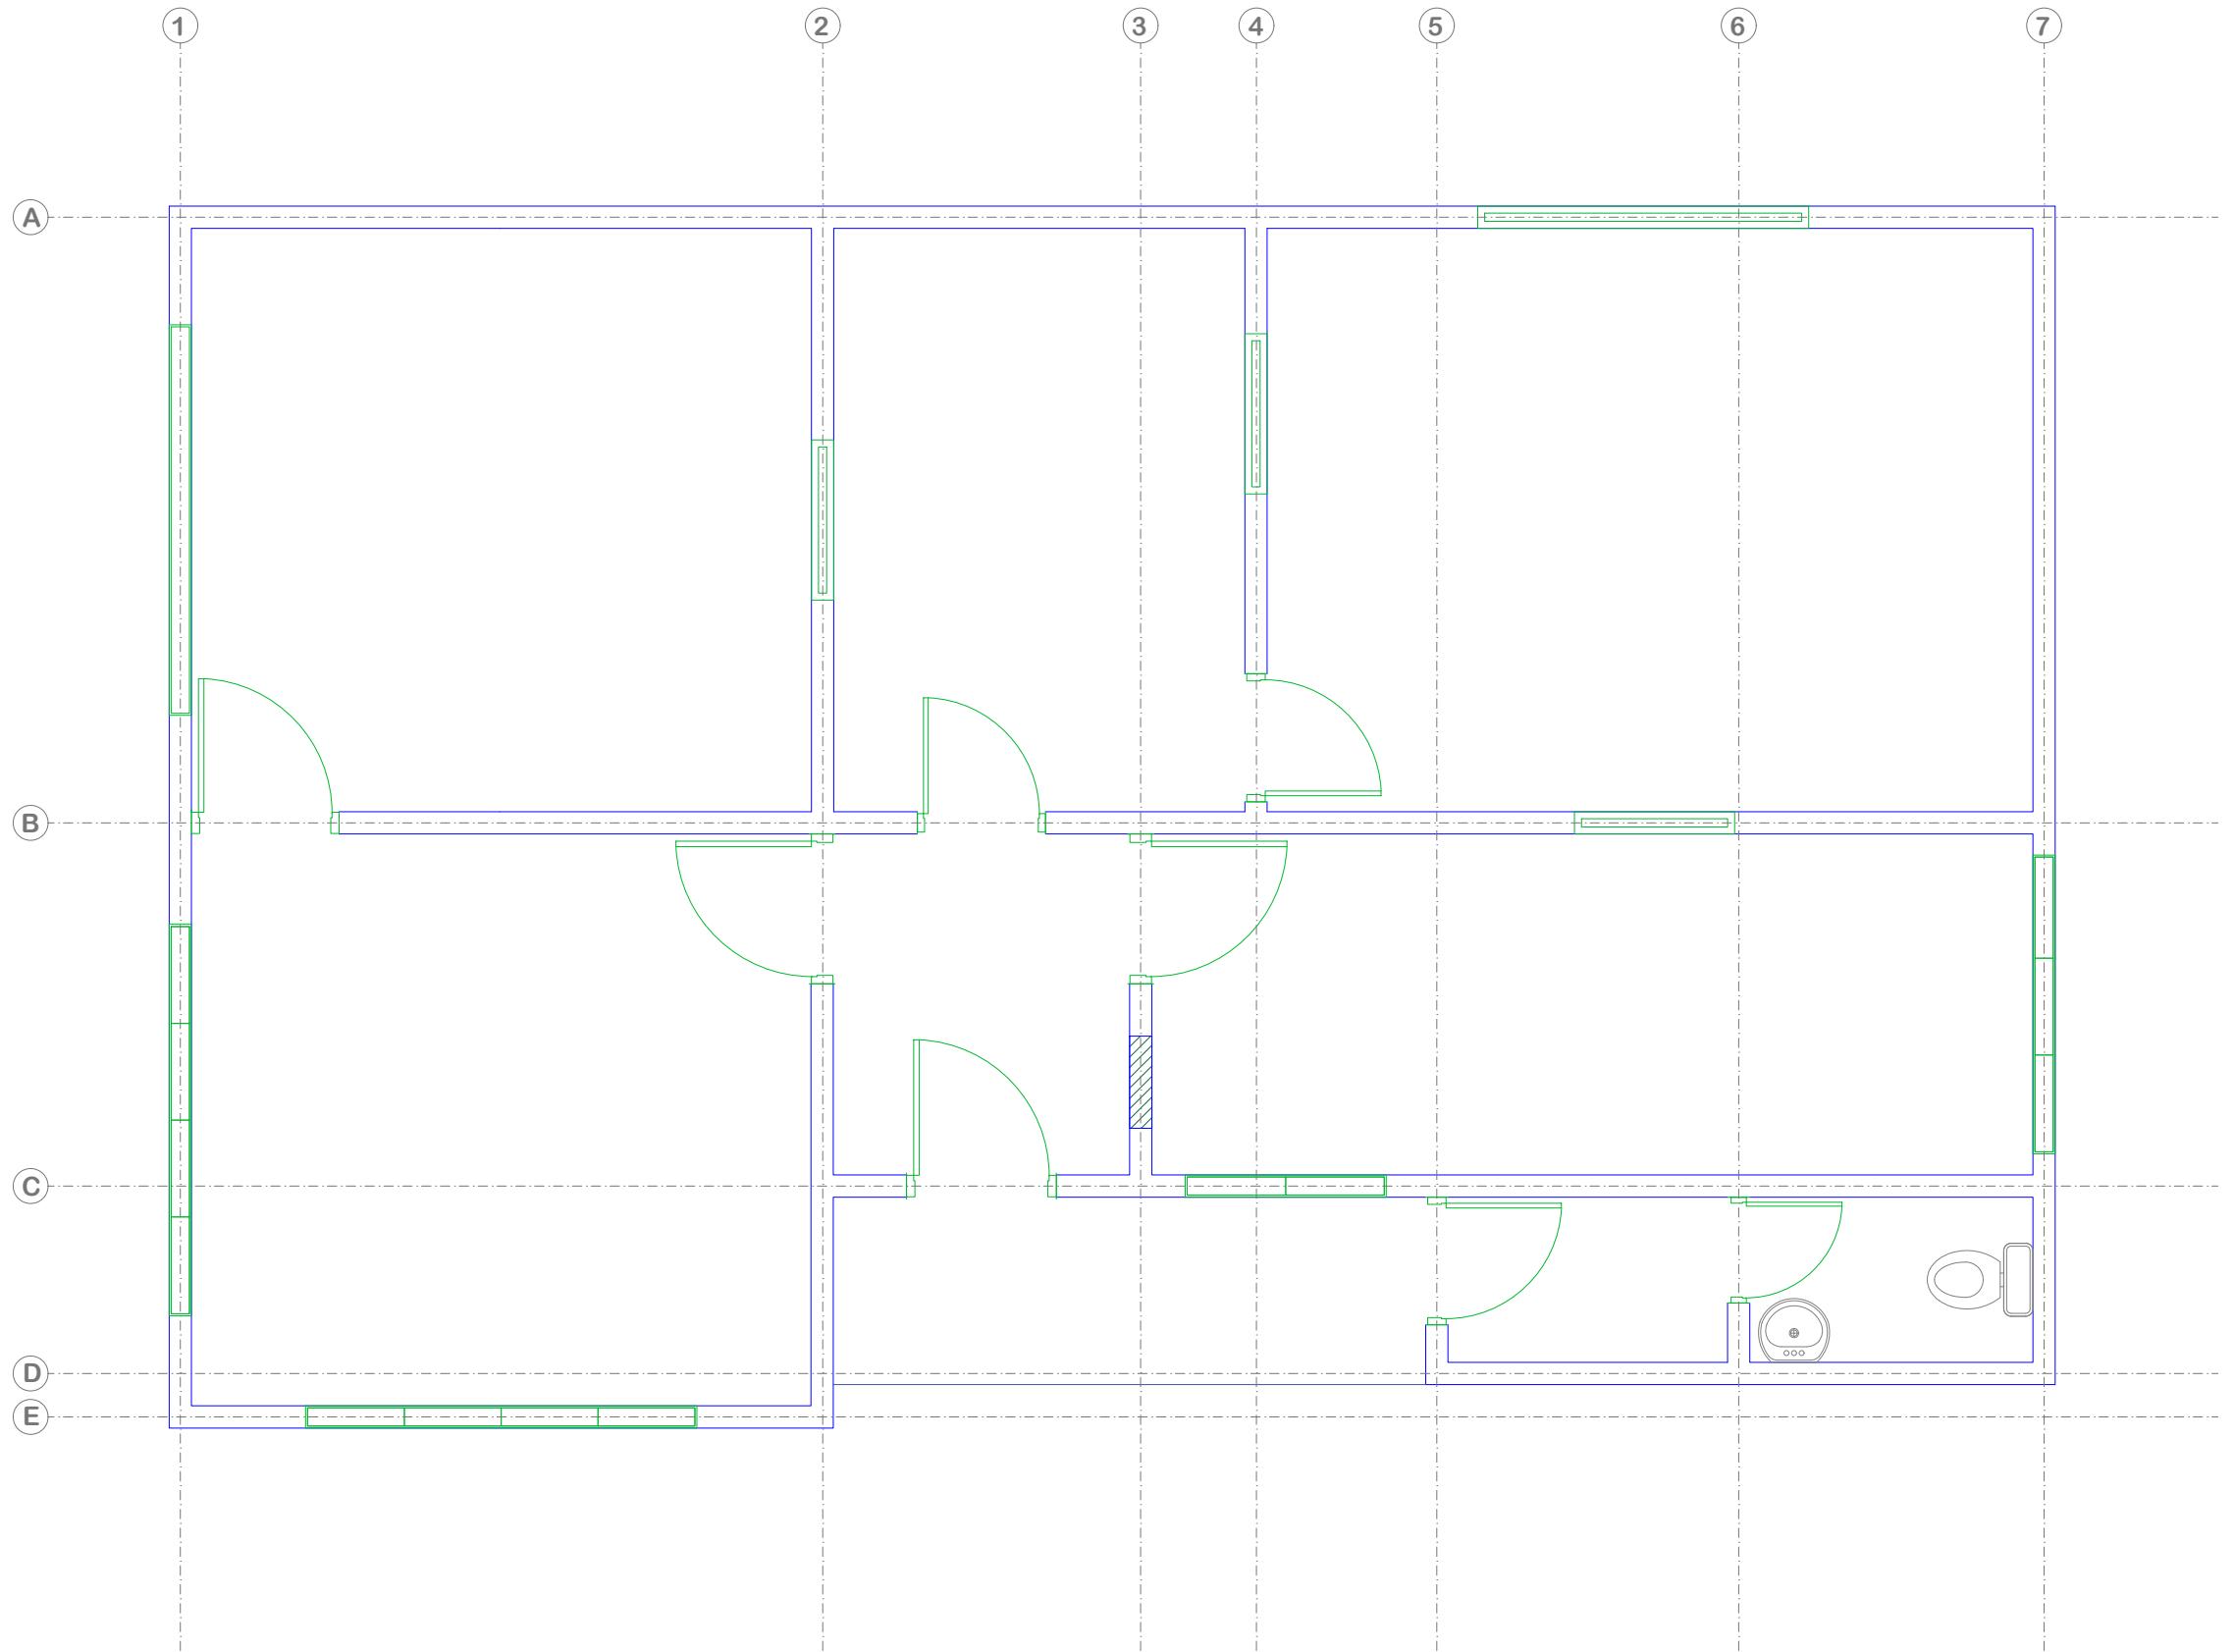

**Project Title:**  
OUTSTATION CALL CENTER

**Dwg title:**  
EXISTING FLOOR PLAN

**Location:**  
FVM MEDIA CENTER

**Department:**  
FACILITIES MANAGEMENT SERVICES


**Design & Drawn:**  
M.SHIFAU

**Date:**  
May 24, 2022

**Scale:**  
---

**Page No:** 2  
**Rev No:** ---

FACILITIES AND MAINTENANCE

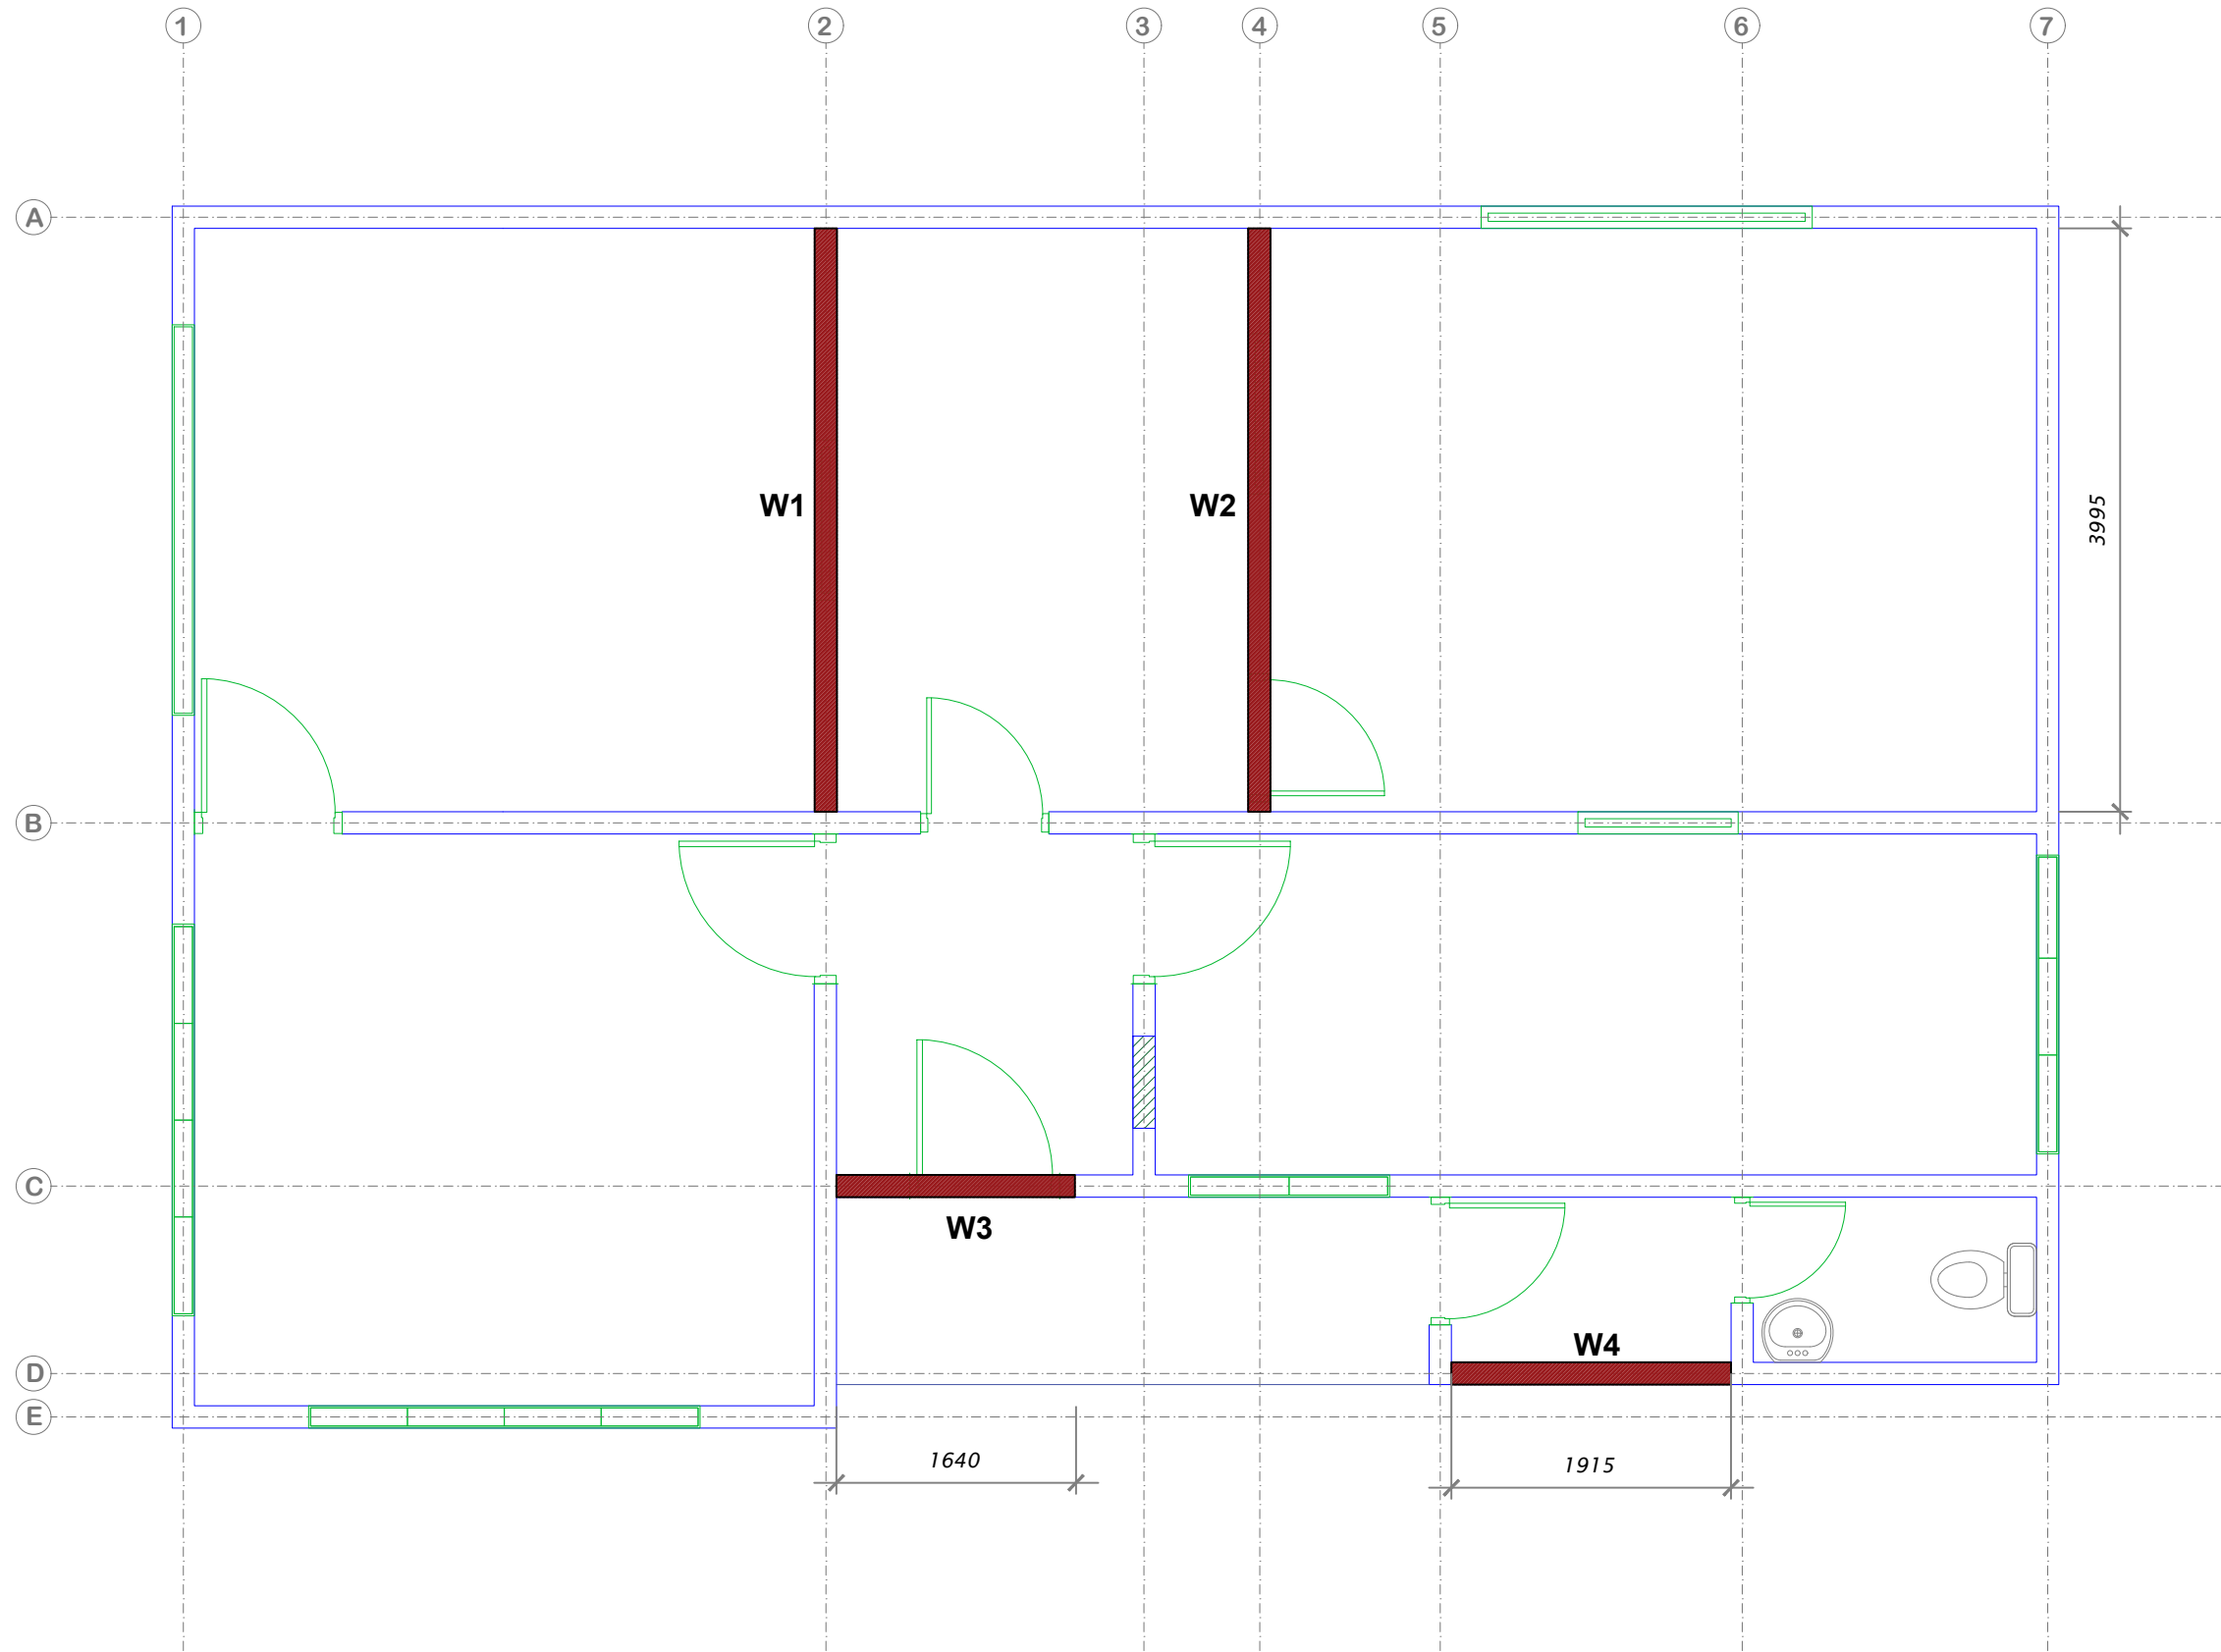

DEMOLITION PLAN

Project Title:  
OUTSTATION CALL CENTER

Dwg title:  
DEMOLITION PLAN

Location:  
FVM MEDIA CENTER

Department:  
FACILITIES MANAGEMENT SERVICES


Design & Drawn:  
M.SHIFAU

Date:  
May 24, 2022

Scale:  
---


Page No: 3  
Rev No: ---

FACILITIES AND MAINTENANCE

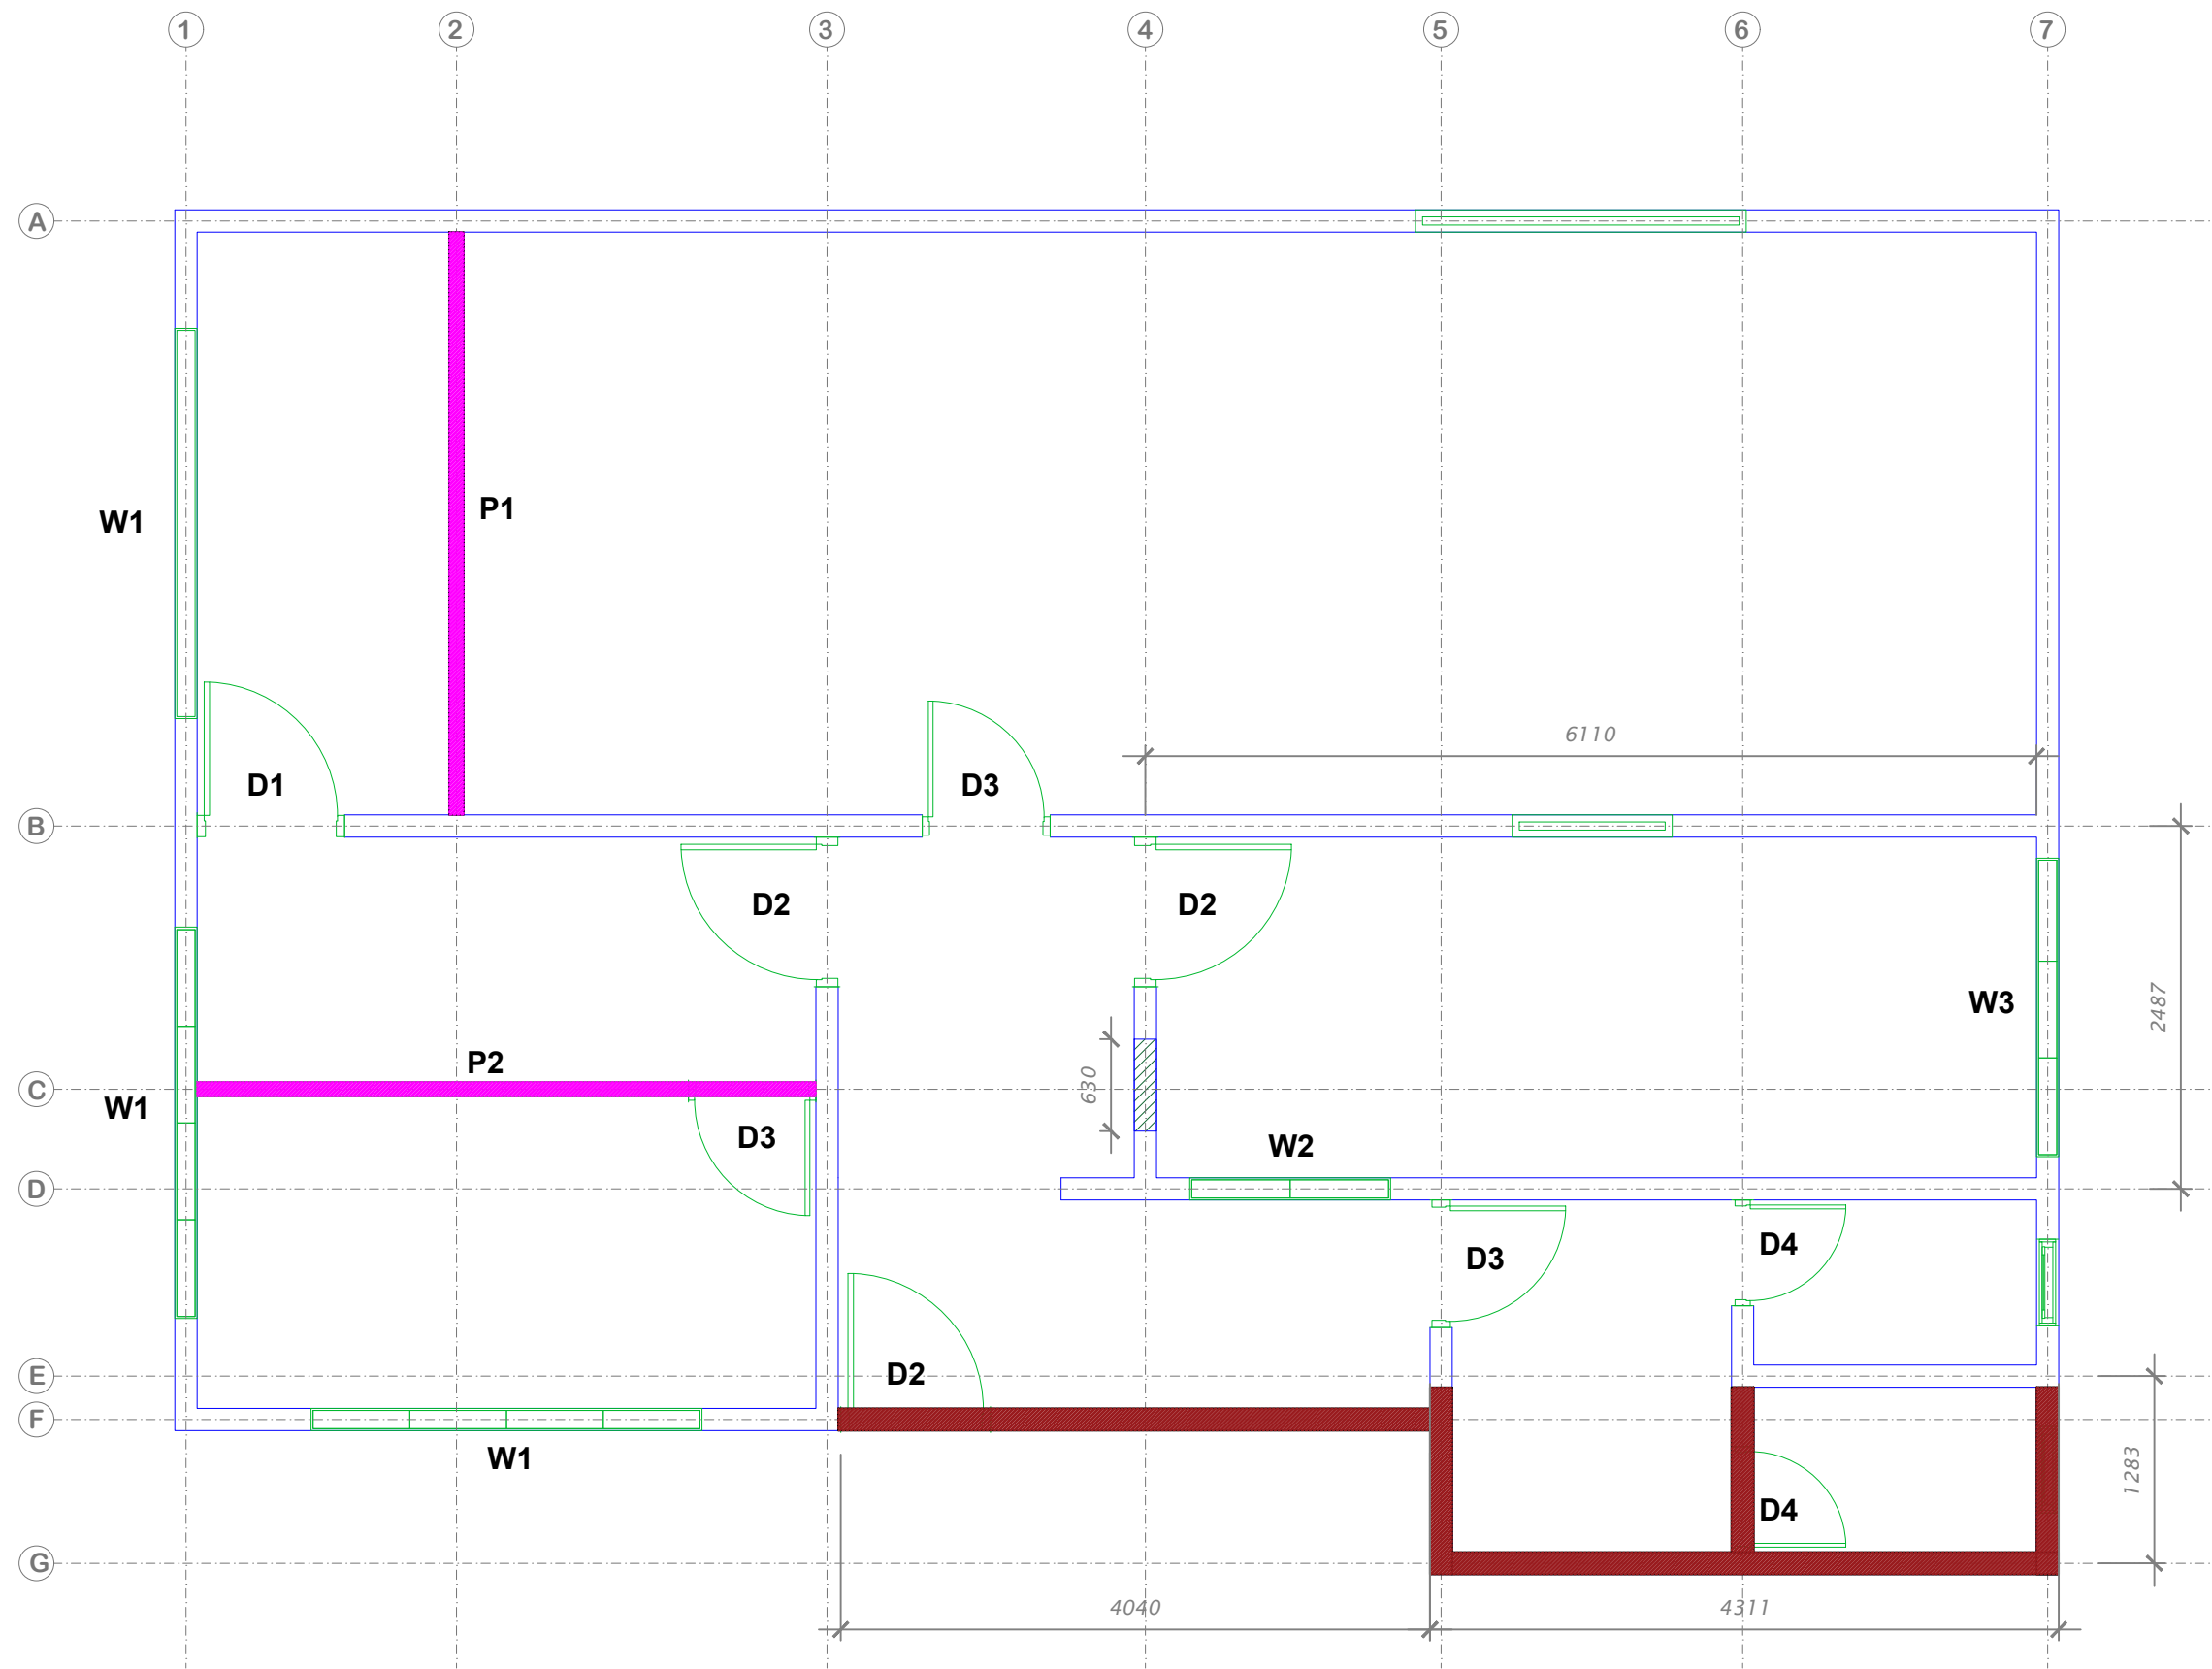






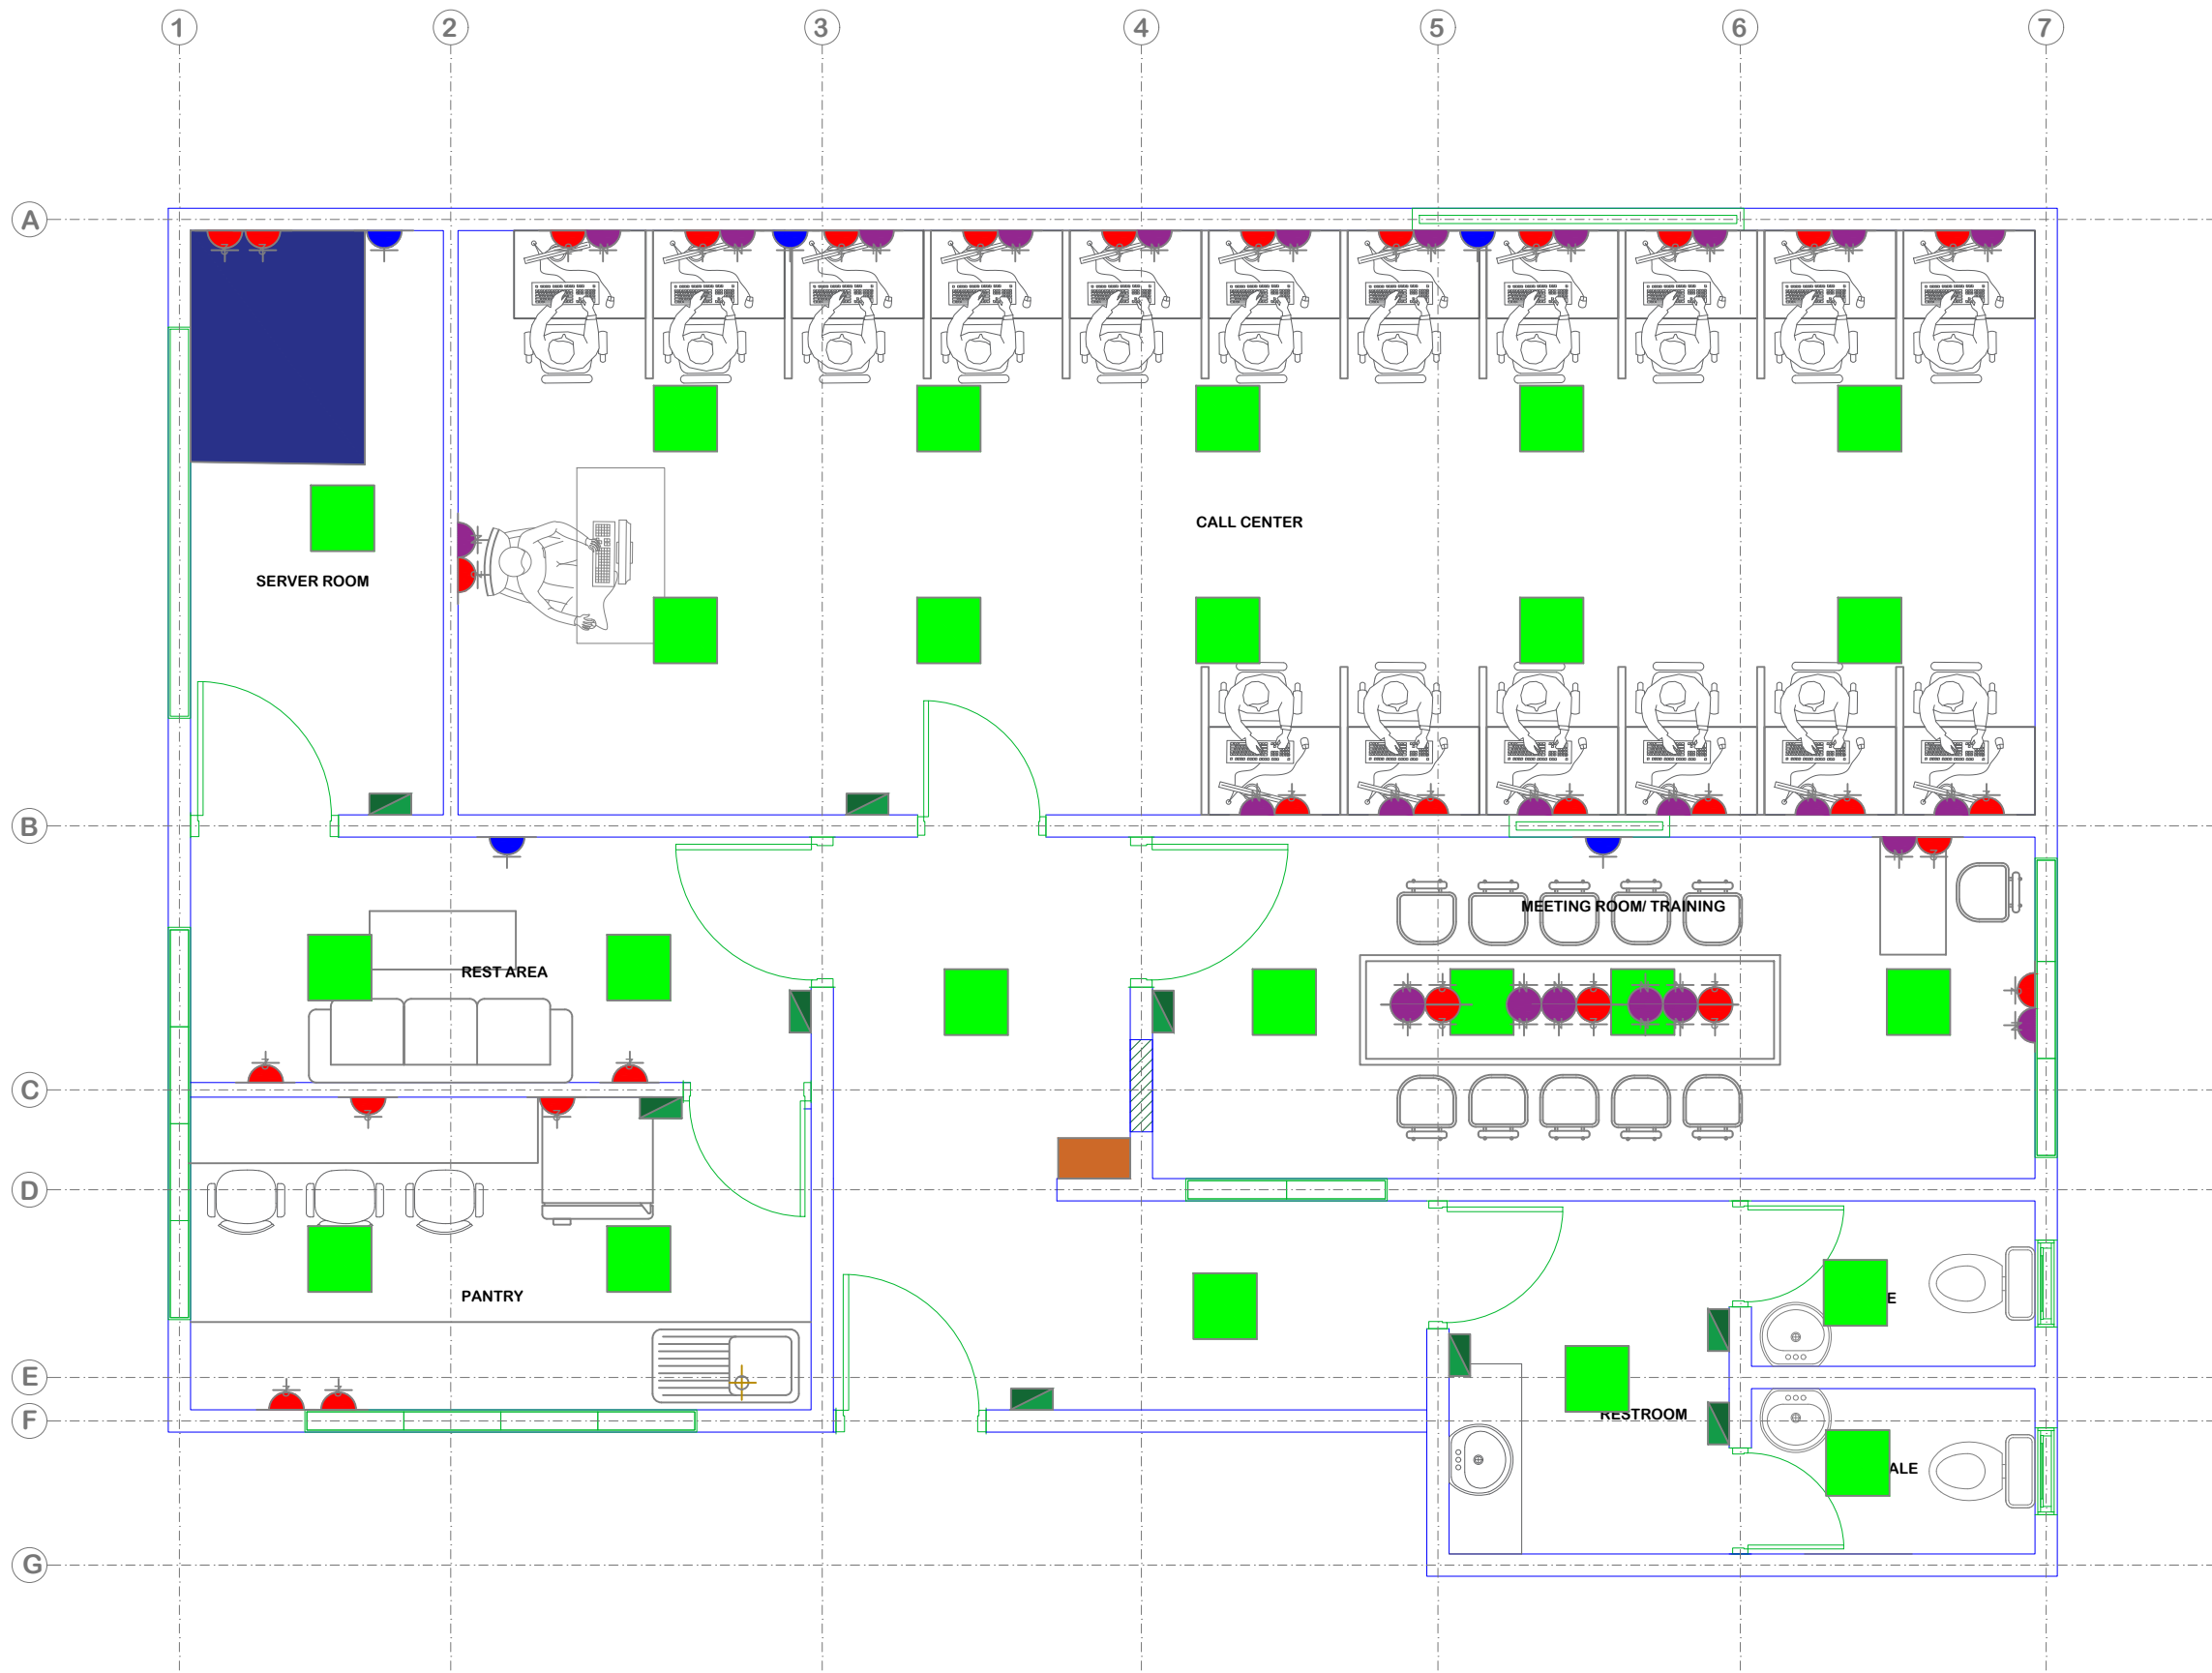


DOORS AND WINDOWS		
#	W	H
D1	897	2130
D2	910	2130
D3	778	2130
D4	643	2100
W1	2683	1651
W2	1377	1651
W3	2051	1651

 - MASONRY WALL
- DRYWALL PARTITION
- WALL HEIGHT: 2590mm



**LEGENDS**

-  18W LED LIGHT 12"
-  13AMP DOUBLE SOCKET
-  CAT-6 NETWORK POINT
-  NETWORK SWITCH
-  DISTRIBUTION BOARD
-  LIGHT SWITCHES
-  15 AMPS POWER SOCKET

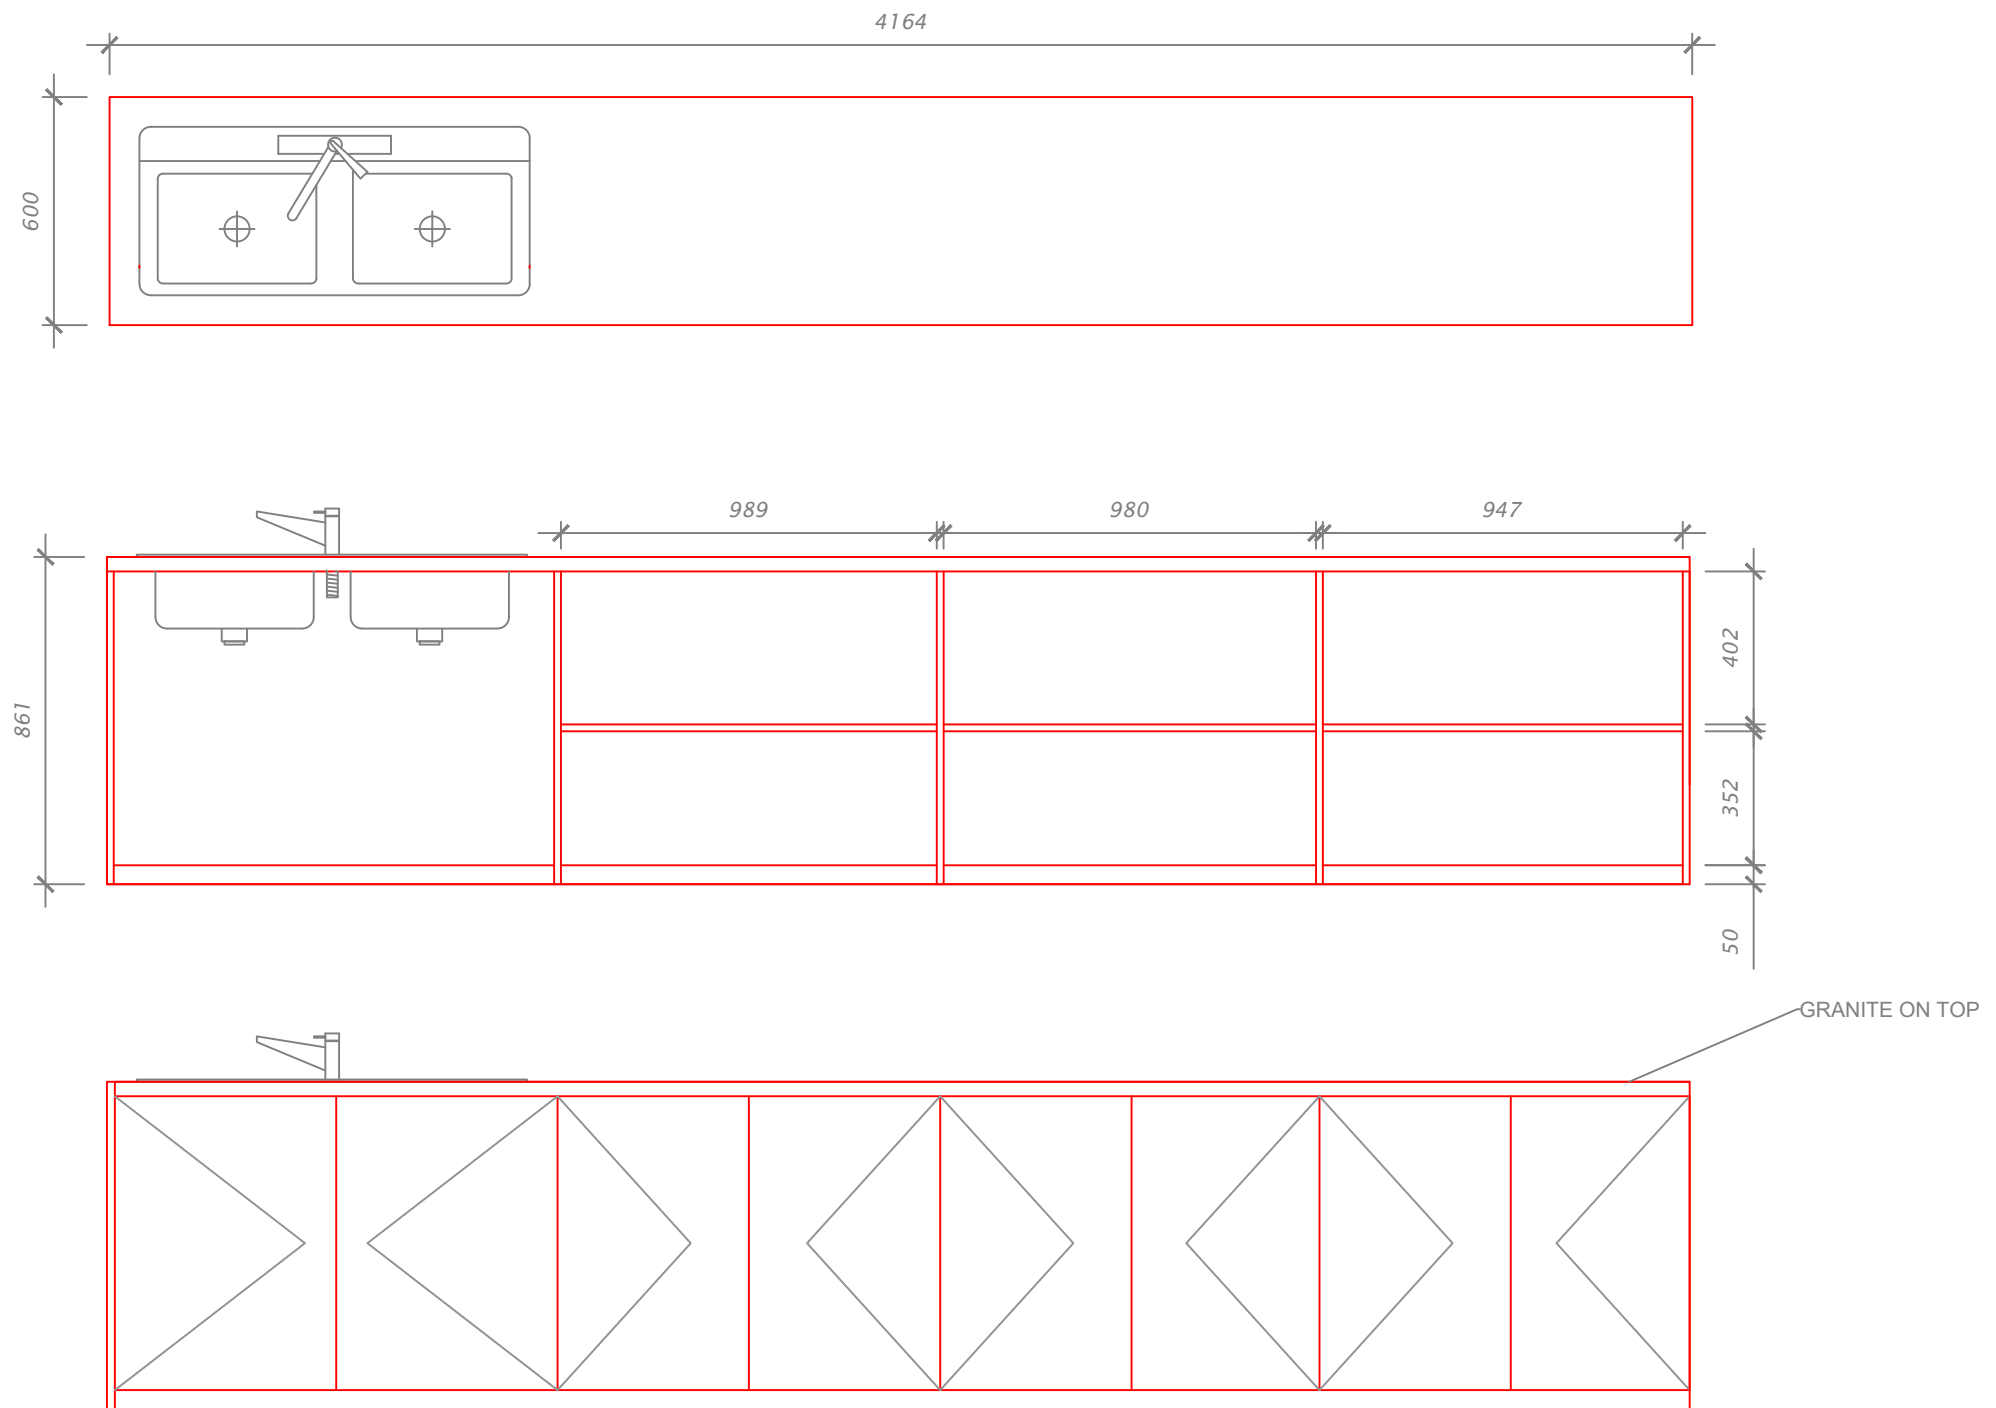

**PANTRY SINK CABINET**

Project Title:  
OUTSTATION CALL CENTER

Dwg title:  
PANTRY SINK CABINET

Location:  
FVM MEDIA CENTER

Department:  
FACILITIES MANAGEMENT SERVICES




Design & Drawn:  
M.SHIFAU

Date:  
May 24, 2022

Scale:  
---

Page No: 6  
Rev No: ---

FACILITIES AND MAINTENANCE

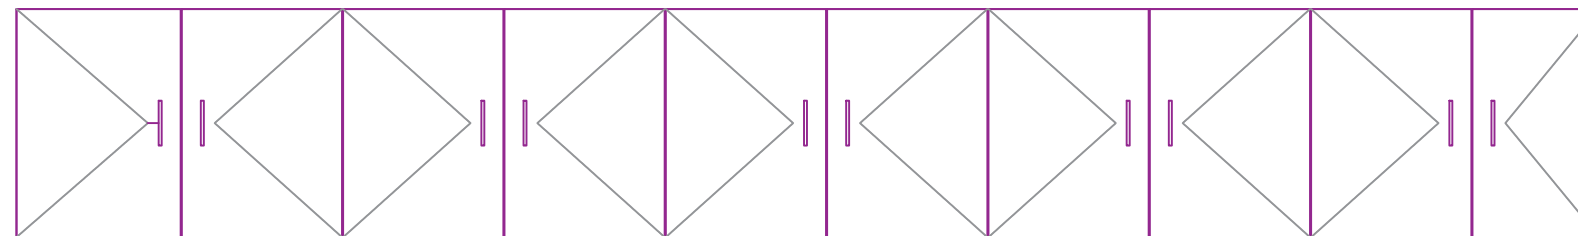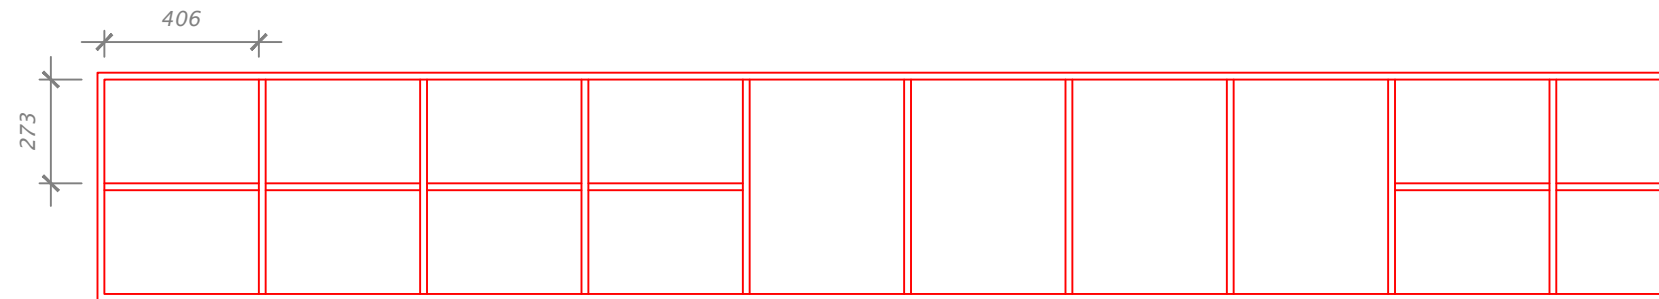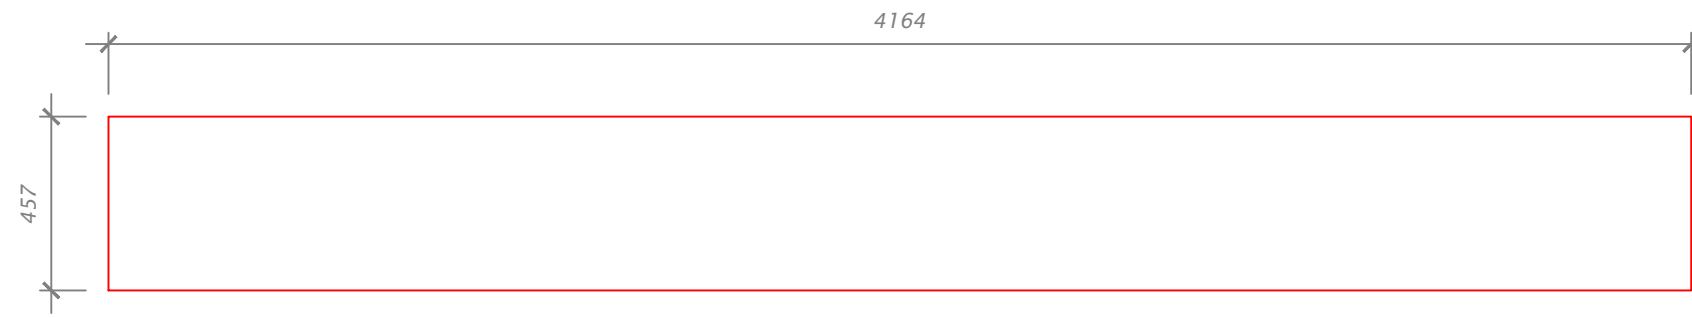

**PANTRY OVERHEAD CABINET**

Project Title:  
OUTSTATION CALL CENTER

Dwg title:  
PANTRY OVERHEAD CABINET

Location:  
FVM MEDIA CENTER

Department:  
FACILITIES MANAGEMENT SERVICES



Design & Drawn:  
M.SHIFAU

Date:  
May 24, 2022

Scale:  
---

Page No: 7  
Rev No: ---

FACILITIES AND MAINTENANCE

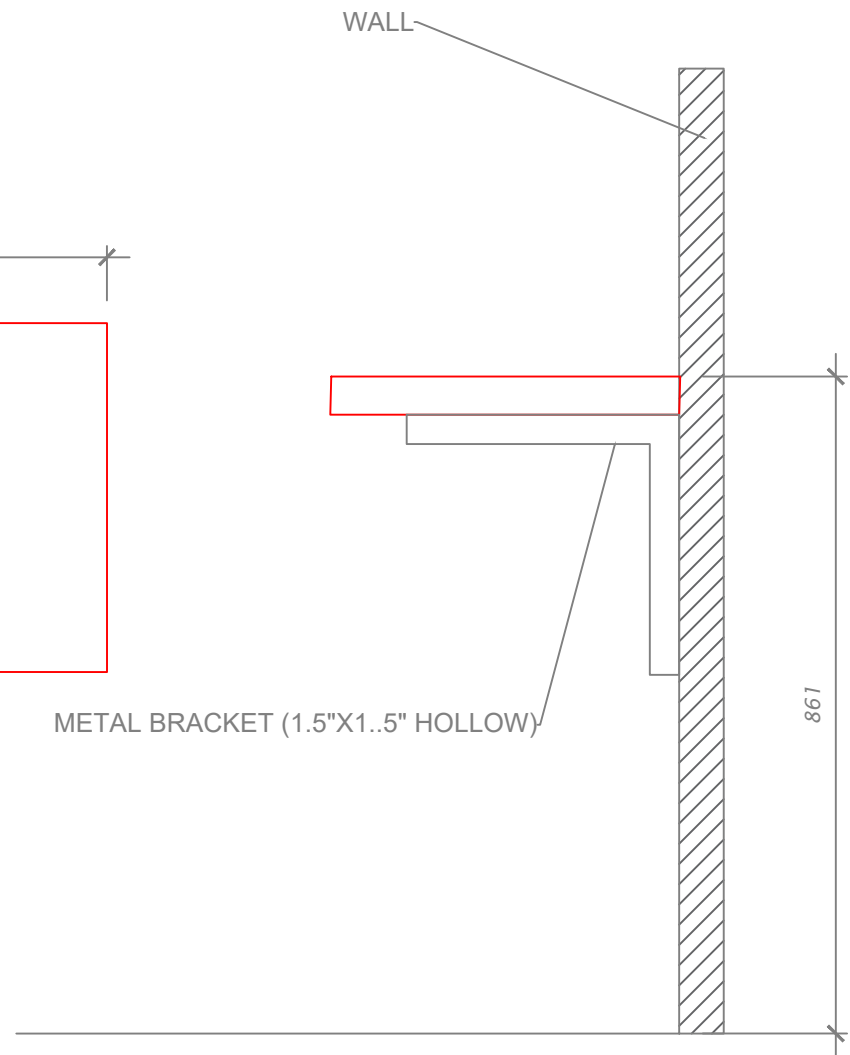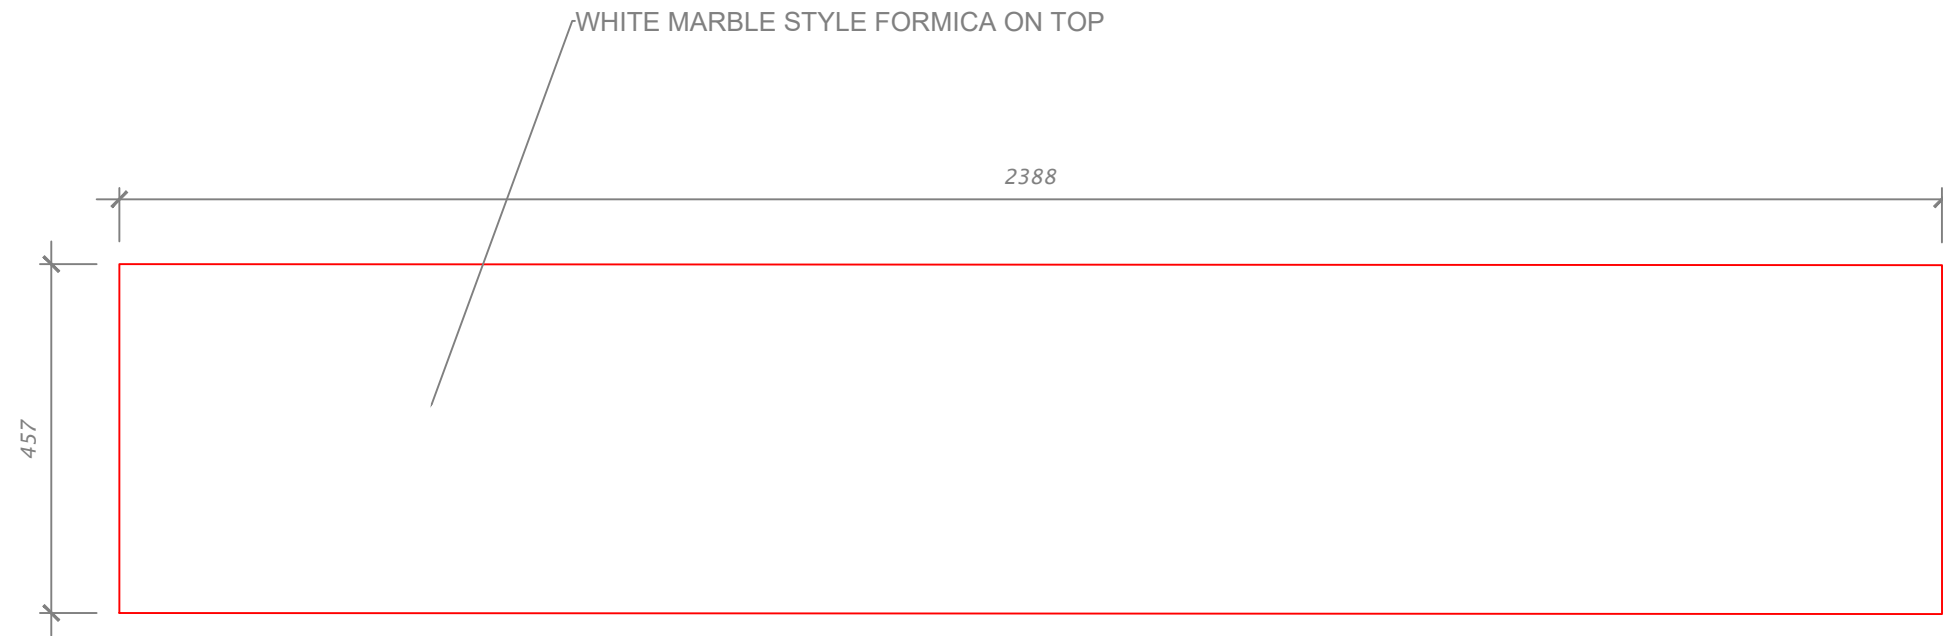

**DINING FLOATING TABLE MOUNTED TO WALL**

Project Title:  
OUTSTATION CALL CENTER

Dwg title:  
PANTRY DINING TABLE

Location:  
FVM MEDIA CENTER

Department:  
FACILITIES MANAGEMENT SERVICES

Design & Drawn:  
M.SHIFAU

Date:  
May 24, 2022

Scale:  
---

Page No: 8  
Rev No: ---

FACILITIES AND MAINTENANCE