

**CONSULTANCY FOR ARCHITECTURAL FIRM FOR THE DESIGNING
AND PREPARATION OF DETAILED DRAWINGS, BOQS AND THE
SUPERVISION OF THE REFURBISHMENTS OF POLYTECHNICS
MALDIVES POLYTECHNIC, K.MALE' CAMPUS
ARCHITECTURAL, STRUCTURAL & SERVICES DRAWINGS**



SEPTEMBER 2021

CONTRACT NO: MEERY/2021/GS-016

CLIENT : MINISTRY OF HIGHER EDUCATION

DESIGN BY

 ArchEng
s t u d i o
Ma Fiyajahage, 1st floor, Male', Republic of Maldives
admin@archeng.biz

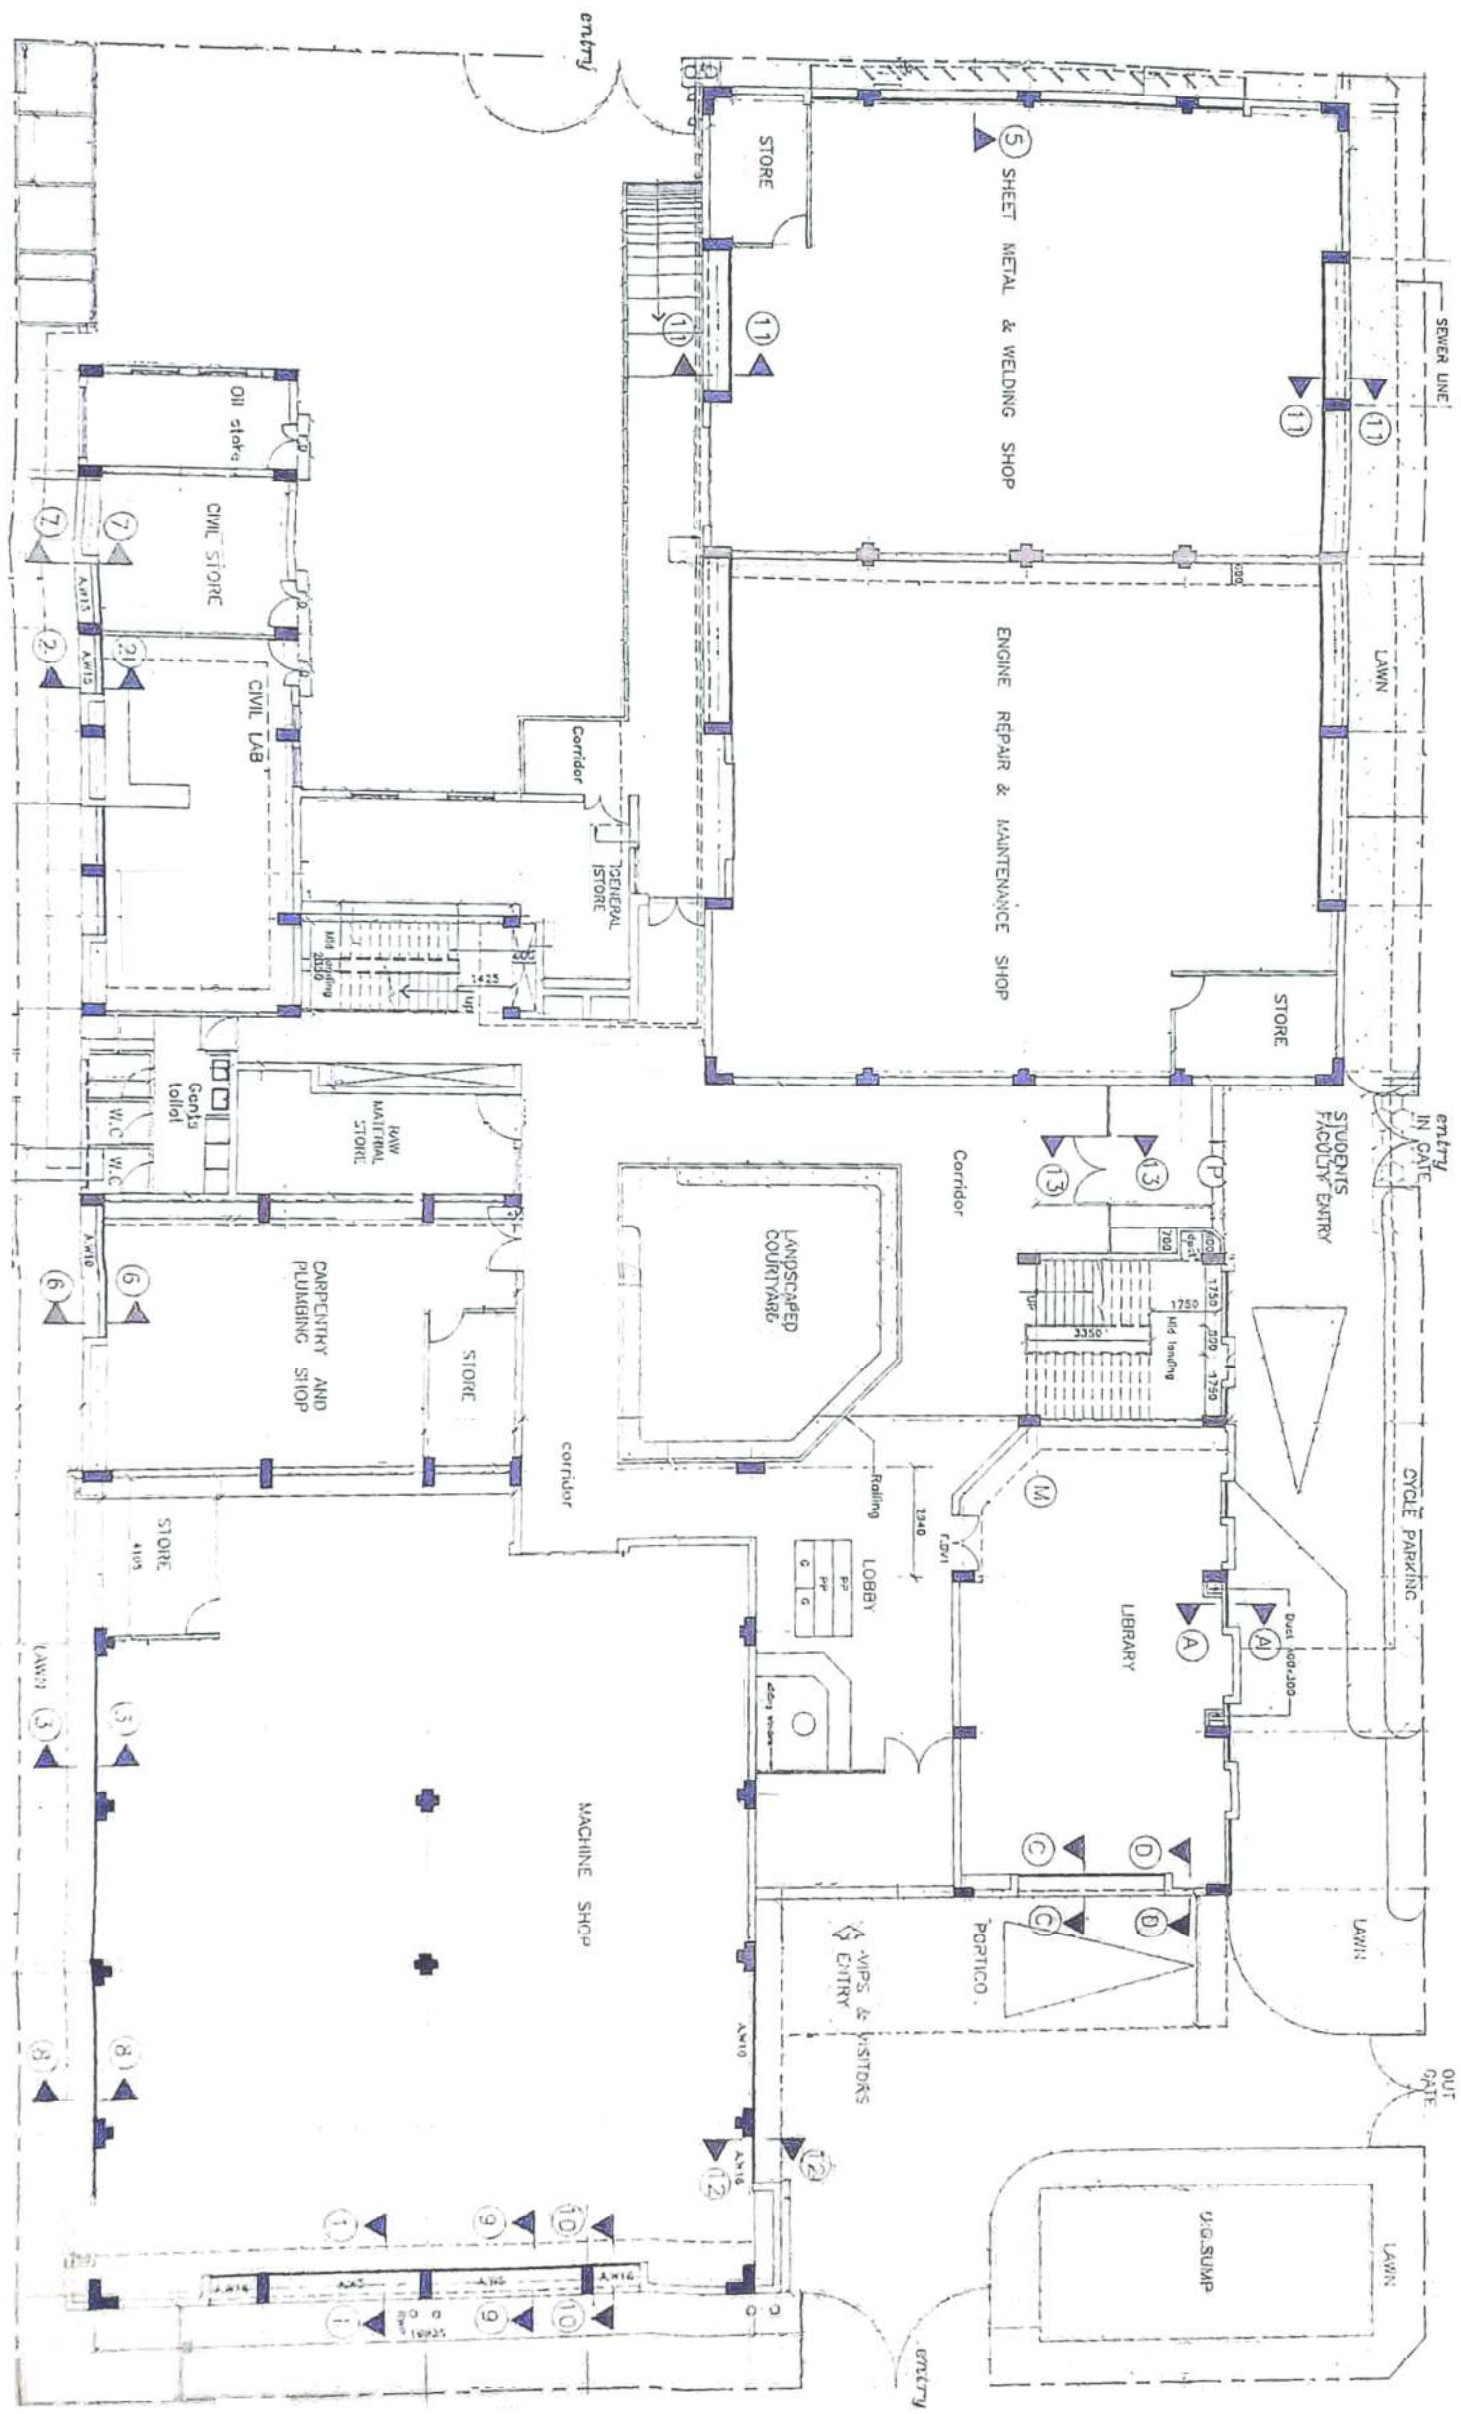


ORIGINAL FLOOR PLANS PROVIDED BY MALDIVES POLYTECHNIC WITH MODIFICATIONS TO REFLECT CURRENT FLOOR PLAN



GROUND FLOOR PLAN

SCALE 1:200

CONTRACTORS MUST CHECK ALL DIMENSIONS ON SITE BEFORE STARTING ANY WORK OR SHOP DRAWINGS. FIGURED DIMENSIONS TO TAKE PRECEDENCE OVER SCALE DIMENSIONS

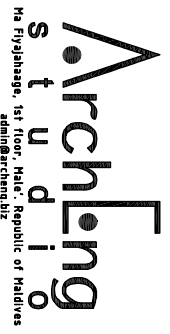


REVISION:	ARCHITECT:	PROJECT:	MALDIVES POLYTECHNIC MALE CAMPUS
	ENGINEER: MARIYAM SAMAH	LOCATION:	K.M.ALE
	ARCHITECTURAL CHECKER:	DRAWING TITLE:	AS GIVEN
	STRUCTURAL CHECKER:	CLIENT:	MINISTRY OF HIGHER EDUCATION
	DRAWN BY: HAWWA NISWA	SCALE: AS GIVEN	DIMENSION: MM
		DATE: SEPTEMBER 2021	
CONCEPT AND DESIGN IN THIS DRAWING ARE THE PROPERTIES OF ARCHENG STUDIO PVT.LTD. UNAUTHORIZED USE OR REPRODUCTION OF PART OF THE DESIGN DRAWINGS OR CONCEPT TO USE IN OTHER PROJECTS OR SITES OTHER THAN SPECIFIED ON THIS DRAWING IS PROHIBITED			DWG NO
			PROJECT NO: 21-001
			A-02

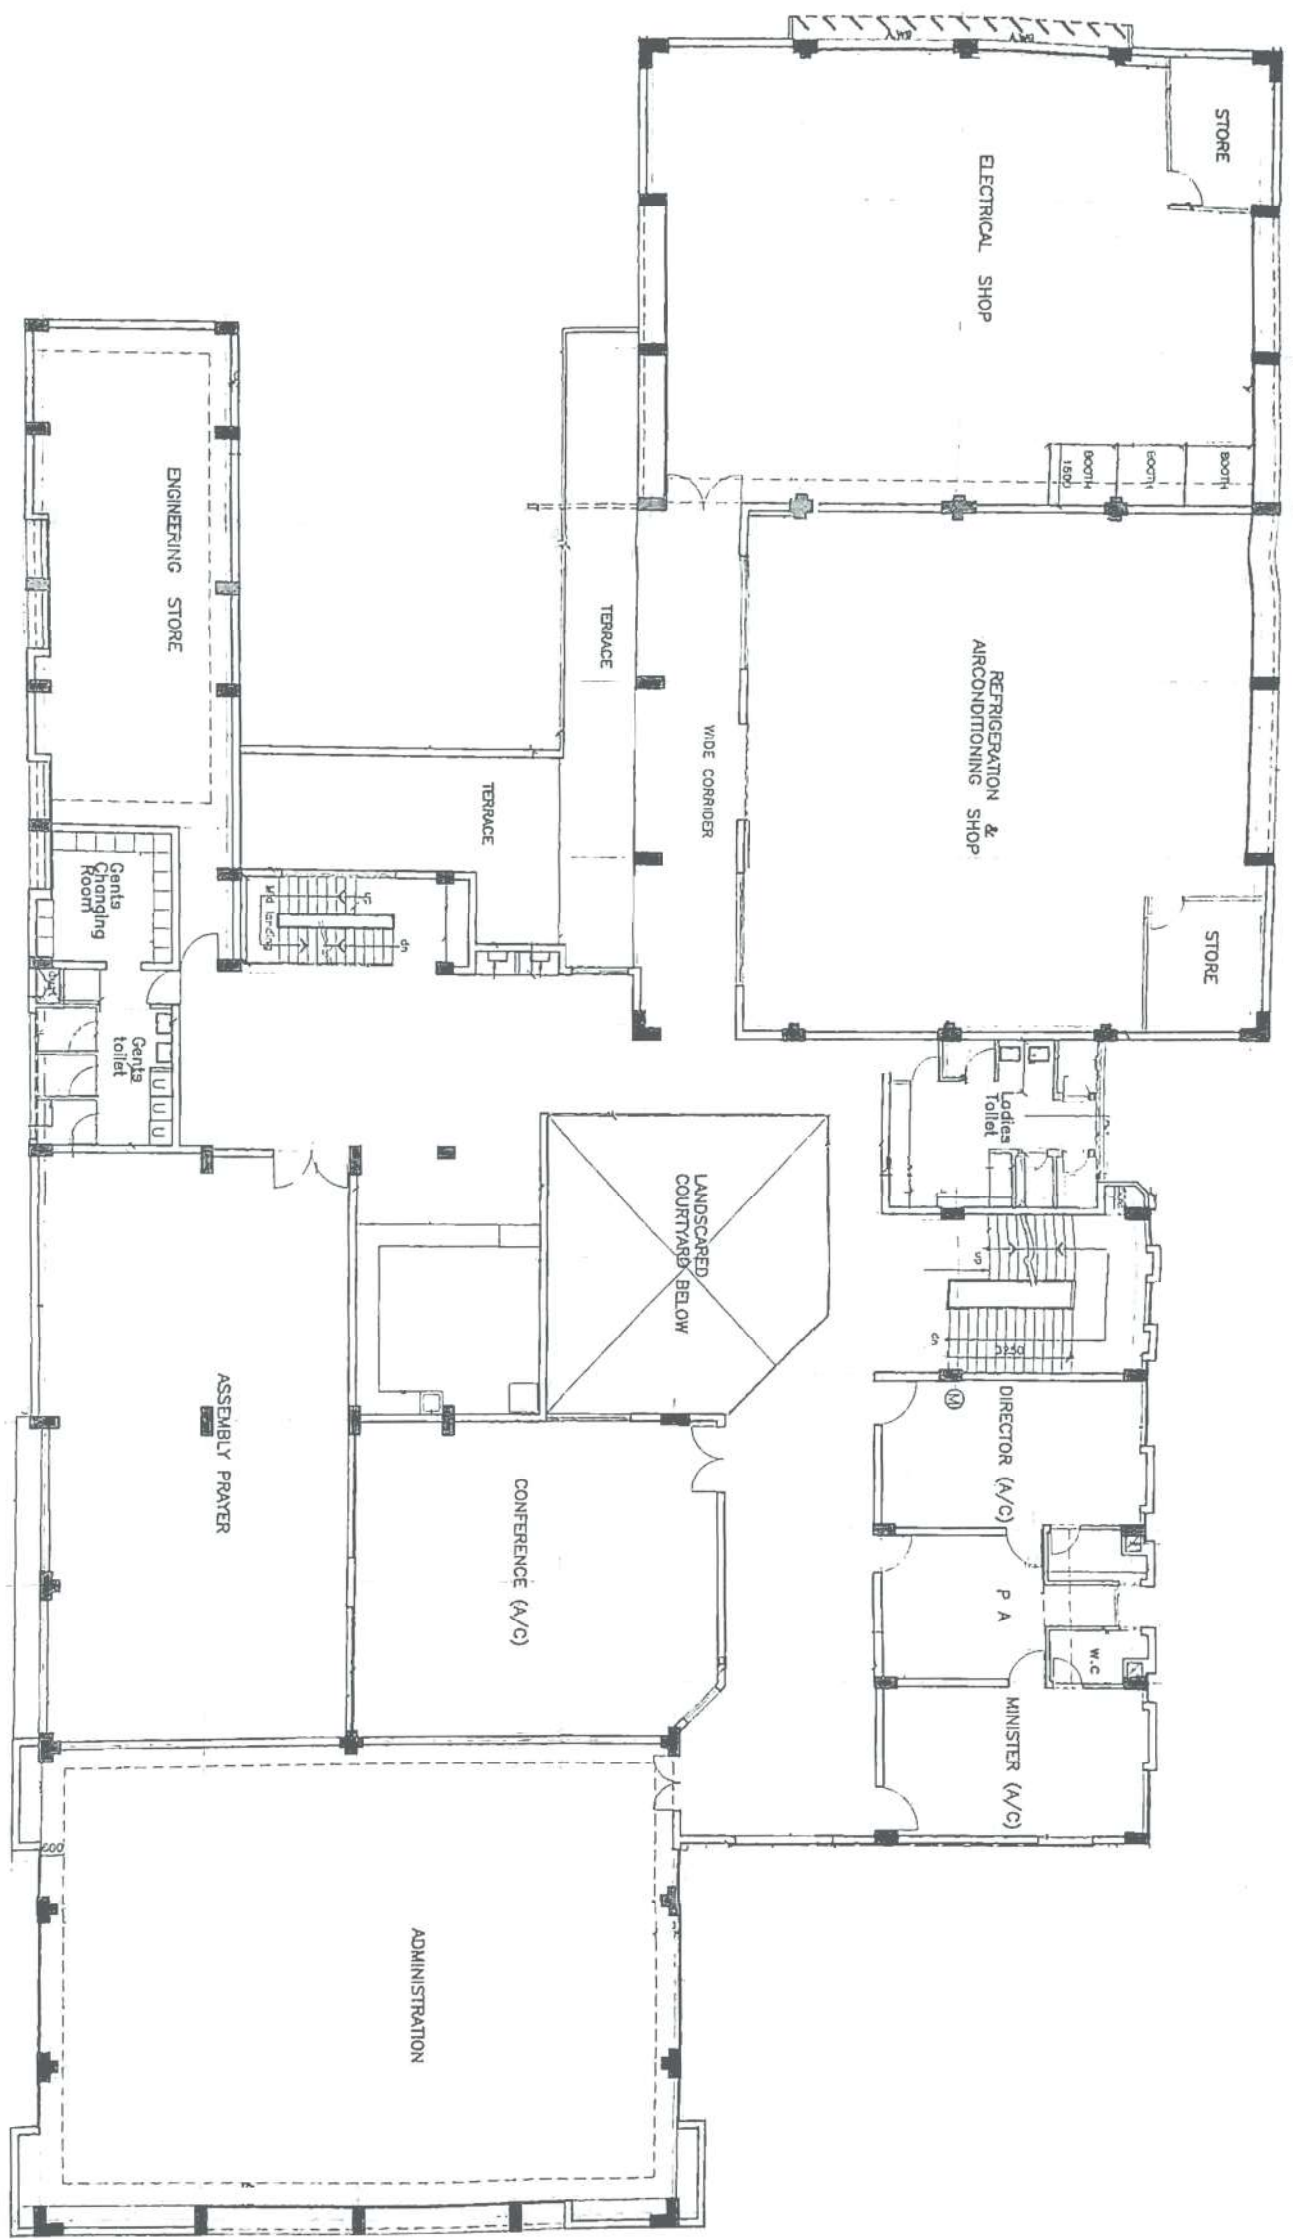 



ORIGINAL FLOOR PLANS PROVIDED BY MALDIVES POLYTECHNIC WITH MODIFICATIONS TO REFLECT CURRENT FLOOR PLAN

FIRST FLOOR PLAN
SCALE 1:200

CONTRACTORS MUST CHECK ALL DIMENSIONS ON SITE BEFORE STARTING ANY WORK OR SHOP DRAWINGS. FIGURED DIMENSIONS TO TAKE PRECEDENCE OVER SCALE DIMENSIONS

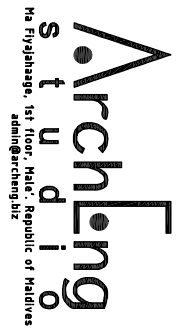

REVISION:	ARCHITECT:	PROJECT:	MALDIVES POLYTECHNIC MALE CAMPUS
	ENGINEER: MARIYAM SAMAH	LOCATION:	K. MALE
	ARCHITECTURAL CHECKER:	DRAWING TITLE:	AS GIVEN
	STRUCTURAL CHECKER:	CLIENT:	MINISTRY OF HIGHER EDUCATION
	DRAWN BY: HAWWA NISWA	SCALE: AS GIVEN	DIMENSION: MM
		DATE: SEPTEMBER 2021	
CONCEPT AND DESIGN IN THIS DRAWING ARE THE PROPERTIES OF ARCHLING STUDIO PVT LTD. UNAUTHORIZED USE OR REPRODUCTION OF PART OF THE DESIGN DRAWINGS OR CONCEPT TO USE IN OTHER PROJECTS OR SITES OTHER THAN SPECIFIED ON THIS DRAWING IS PROHIBITED			DWG NO
			PROJECT NO: 21-001
			A-03

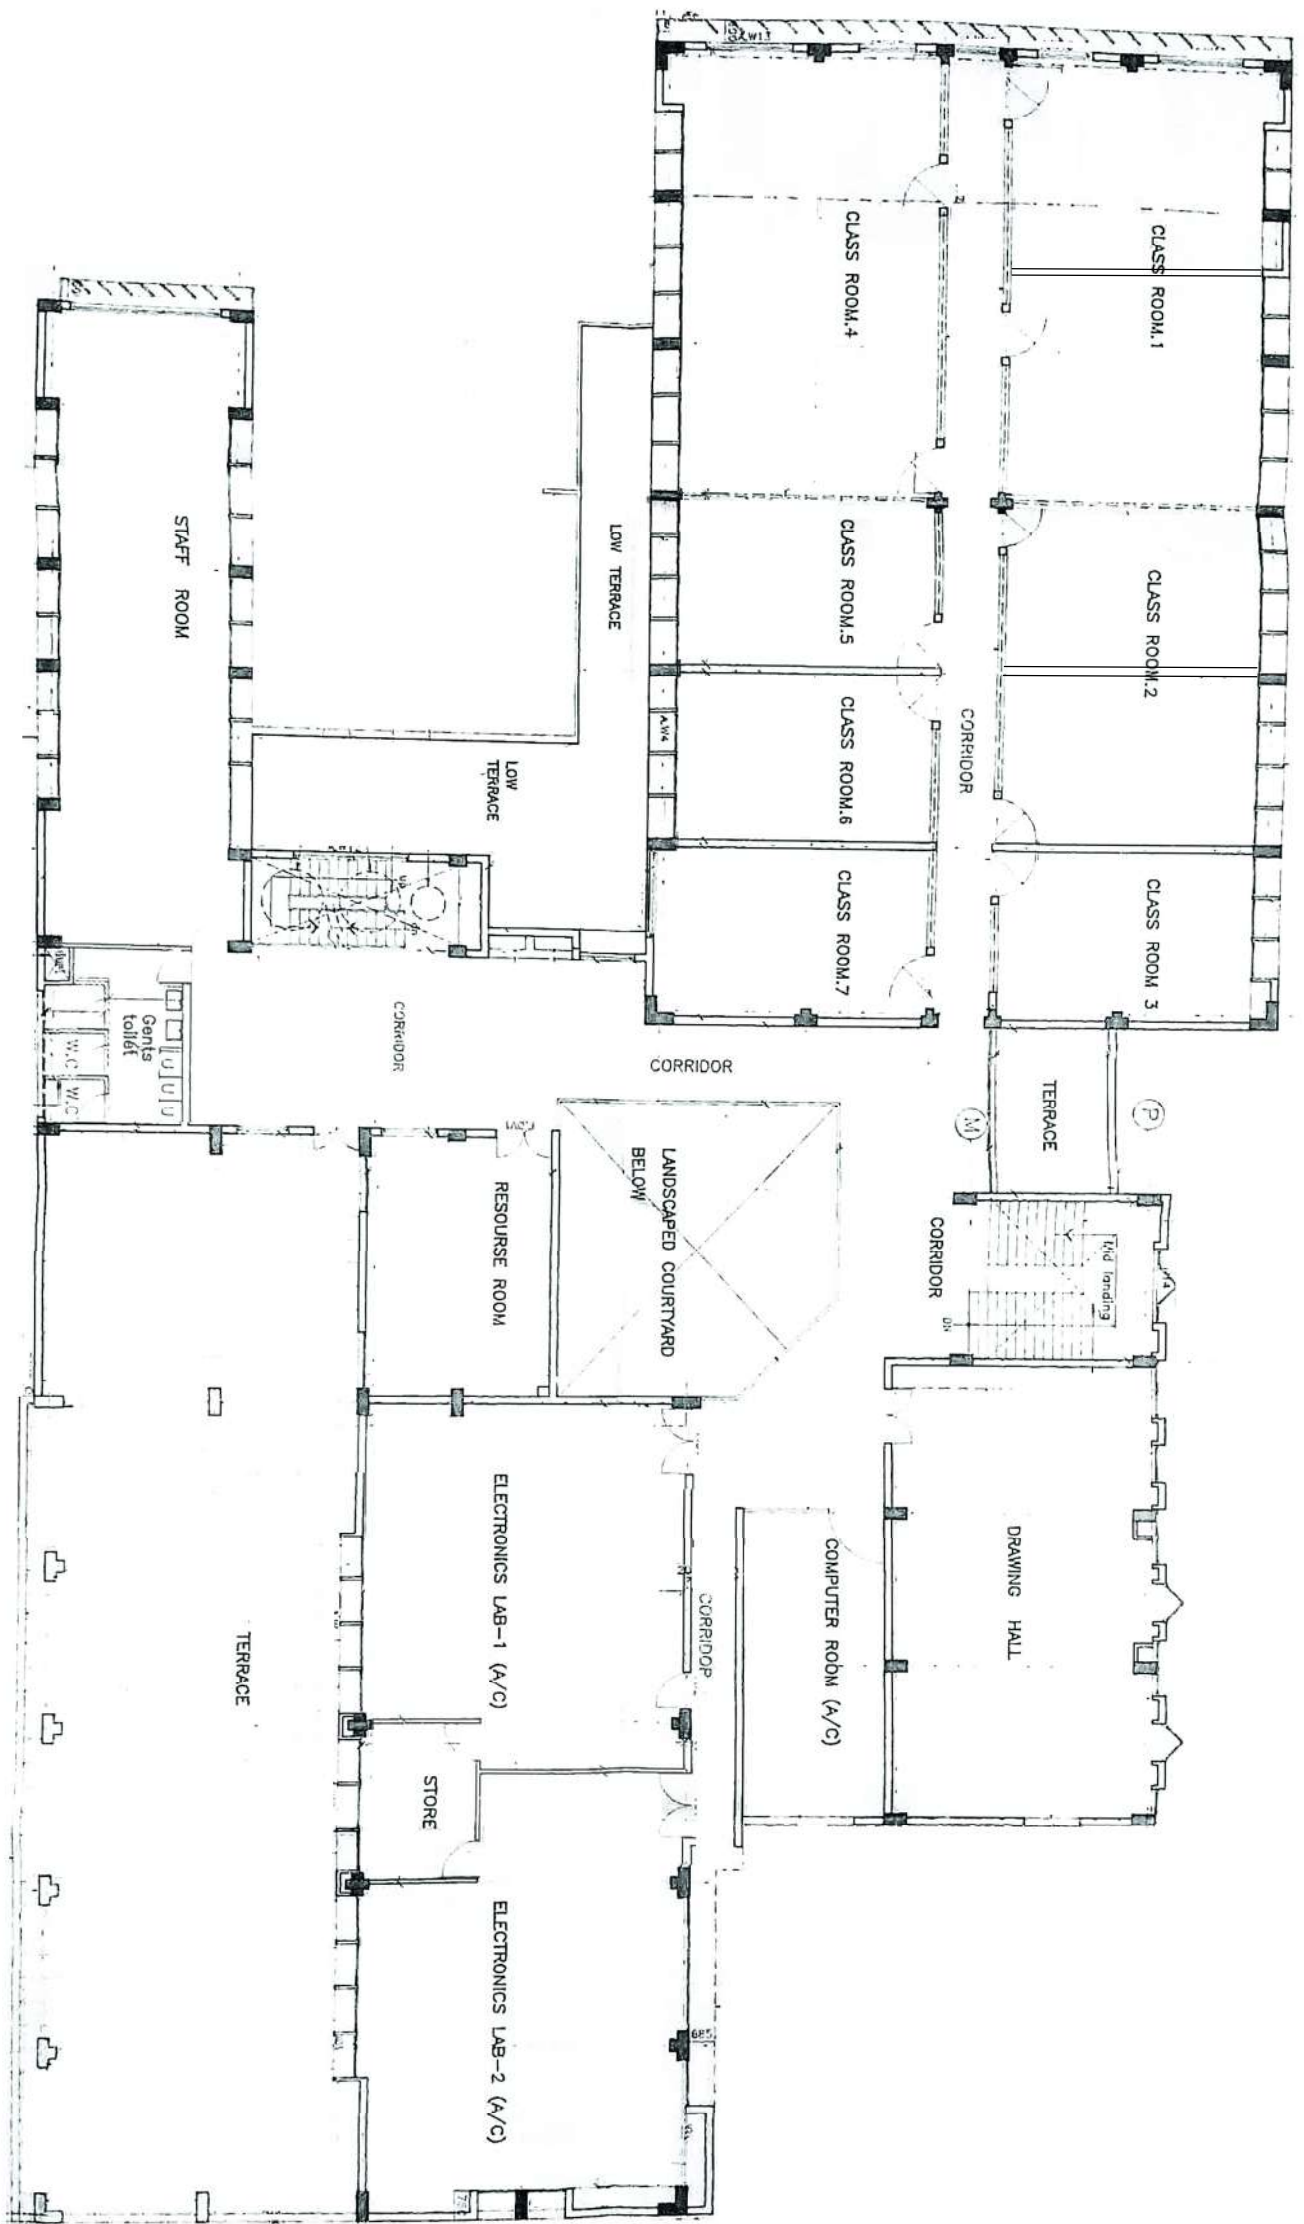 


ORIGINAL FLOOR PLANS PROVIDED BY MALDIVES POLYTECHNIC WITH MODIFICATIONS TO REFLECT CURRENT FLOOR PLAN



SECOND FLOOR PLAN

SCALE 1:200

CONTRACTORS MUST CHECK ALL DIMENSIONS ON SITE BEFORE STARTING ANY WORK OR SHOP DRAWINGS. FIGURED DIMENSIONS TO TAKE PRECEDENCE OVER SCALE DIMENSIONS

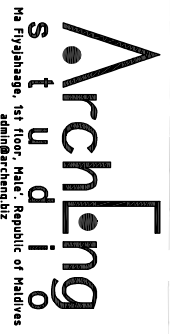


REVISION:	ARCHITECT:	PROJECT:	H. HATHIHUGE, ALL PROPOSED 07 STOREY BUILDING
	ENGINEER: MAARIYAN SAMAH	LOCATION:	K. MALE
	ARCHITECTURAL CHECKER:	DRAWING TITLE:	AS GIVEN
	STRUCTURAL CHECKER:	CLIENT:	MR. ADAM SALEEM
	DRAWN BY: HAWWA NISWA	SCALE: AS GIVEN	DIMENSION: MM
		DATE: SEPTEMBER 2021	
CONCEPT AND DESIGN IN THIS DRAWING ARE THE PROPERTIES OF ARCHENG STUDIO PVT. LTD. UNAUTHORIZED USE OR REPRODUCTION OF PART OF THE DESIGN DRAWINGS OR CONCEPT TO USE IN OTHER PROJECTS OR SITES OTHER THAN SPECIFIED ON THIS DRAWING IS PROHIBITED		DWG NO:	A-04
		PROJECT NO:	21-001

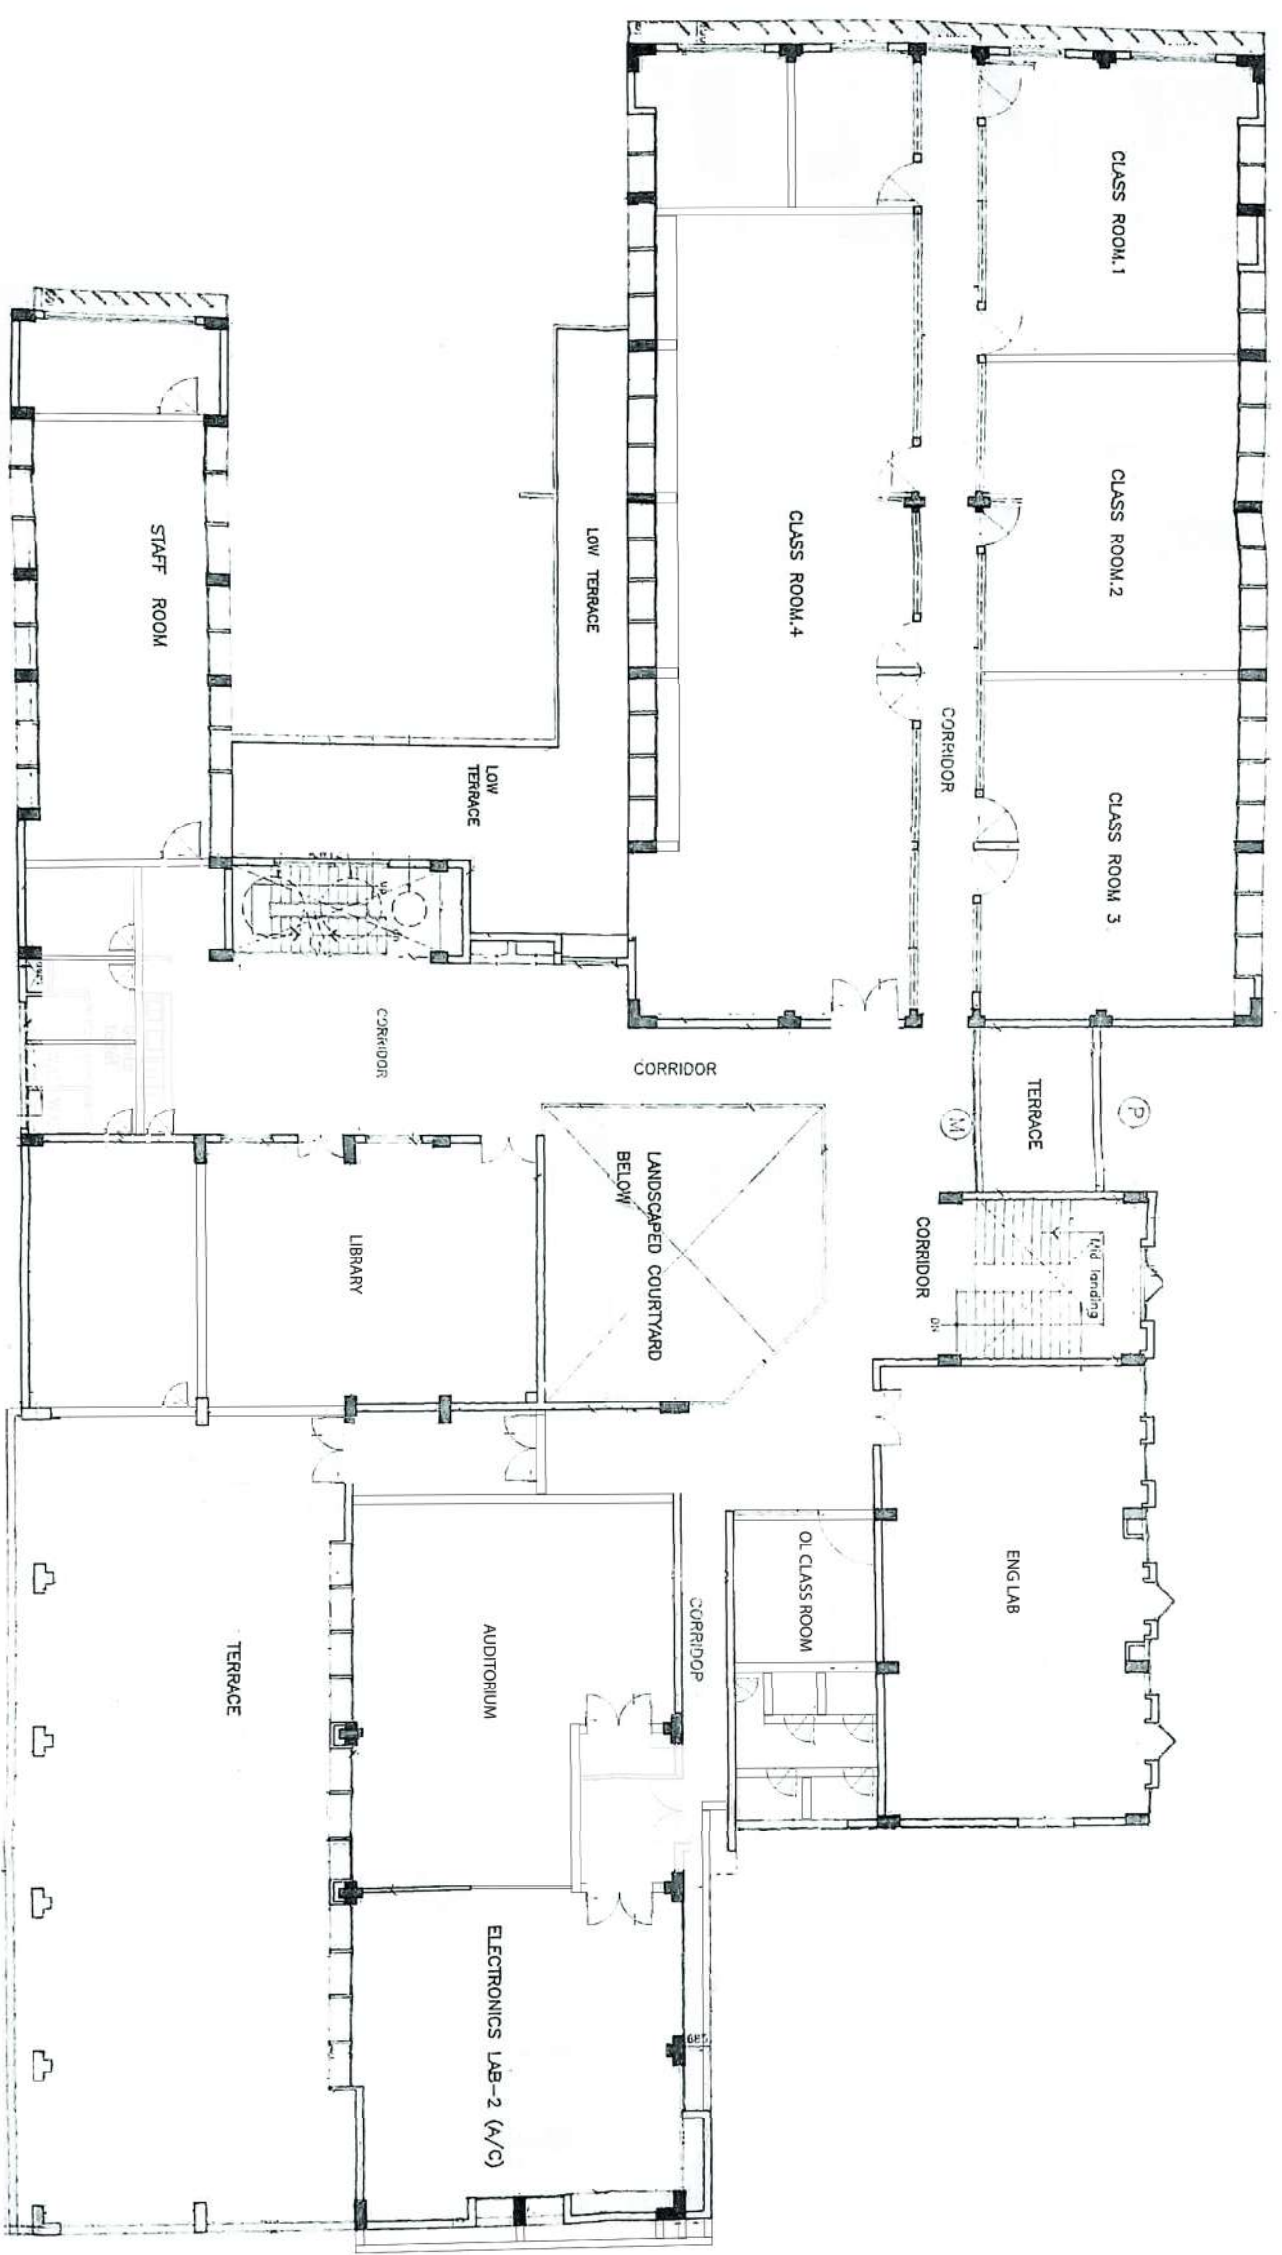 

ORIGINAL FLOOR PLANS PROVIDED BY MALDIVES POLYTECHNIC WITH MODIFICATIONS TO REFLECT CURRENT FLOOR PLAN



THIRD FLOOR PLAN
SCALE 1:200

CONTRACTORS MUST CHECK ALL DIMENSIONS ON SITE BEFORE STARTING ANY WORK OR SHOP DRAWINGS REQUIRED DIMENSIONS TO TAKE FROM THESE DRAWINGS TO TAKE SCALE READINGS

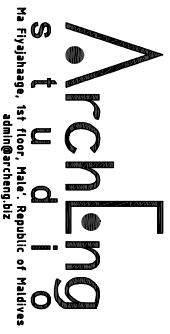

REVISION:	ARCHITECT:	PROJECT:	DWG NO
	ENGINEER: MARIYAM SAMAH	HEATHHUGE ALI, PROPOSED 07 STOREY BUILDING	A-05
	ARCHITECTURAL CHECKER:	LOCATION: K.MALE	PROJECT NO: 21-001
	STRUCTURAL CHECKER:	DRAWING TITLE: AS GIVEN	
	DRAWN BY: HAWWA NISWA	CLIENT: MR. ADAM SALEEM	
		SCALE: AS GIVEN	
		DIMENSION: MM	
		DATE: SEPTEMBER 2021	


CONCEPT AND DESIGN IN THIS DRAWING ARE THE PROPERTIES OF ARCHENG STUDIO PVT.LTD. UNAUTHORIZED USE OR REPRODUCTION OF PART OF THE DESIGN DRAWINGS OR CONCEPT TO USE IN OTHER PROJECTS OR SITES OTHER THAN SPECIFIED ON THIS DRAWING IS PROHIBITED

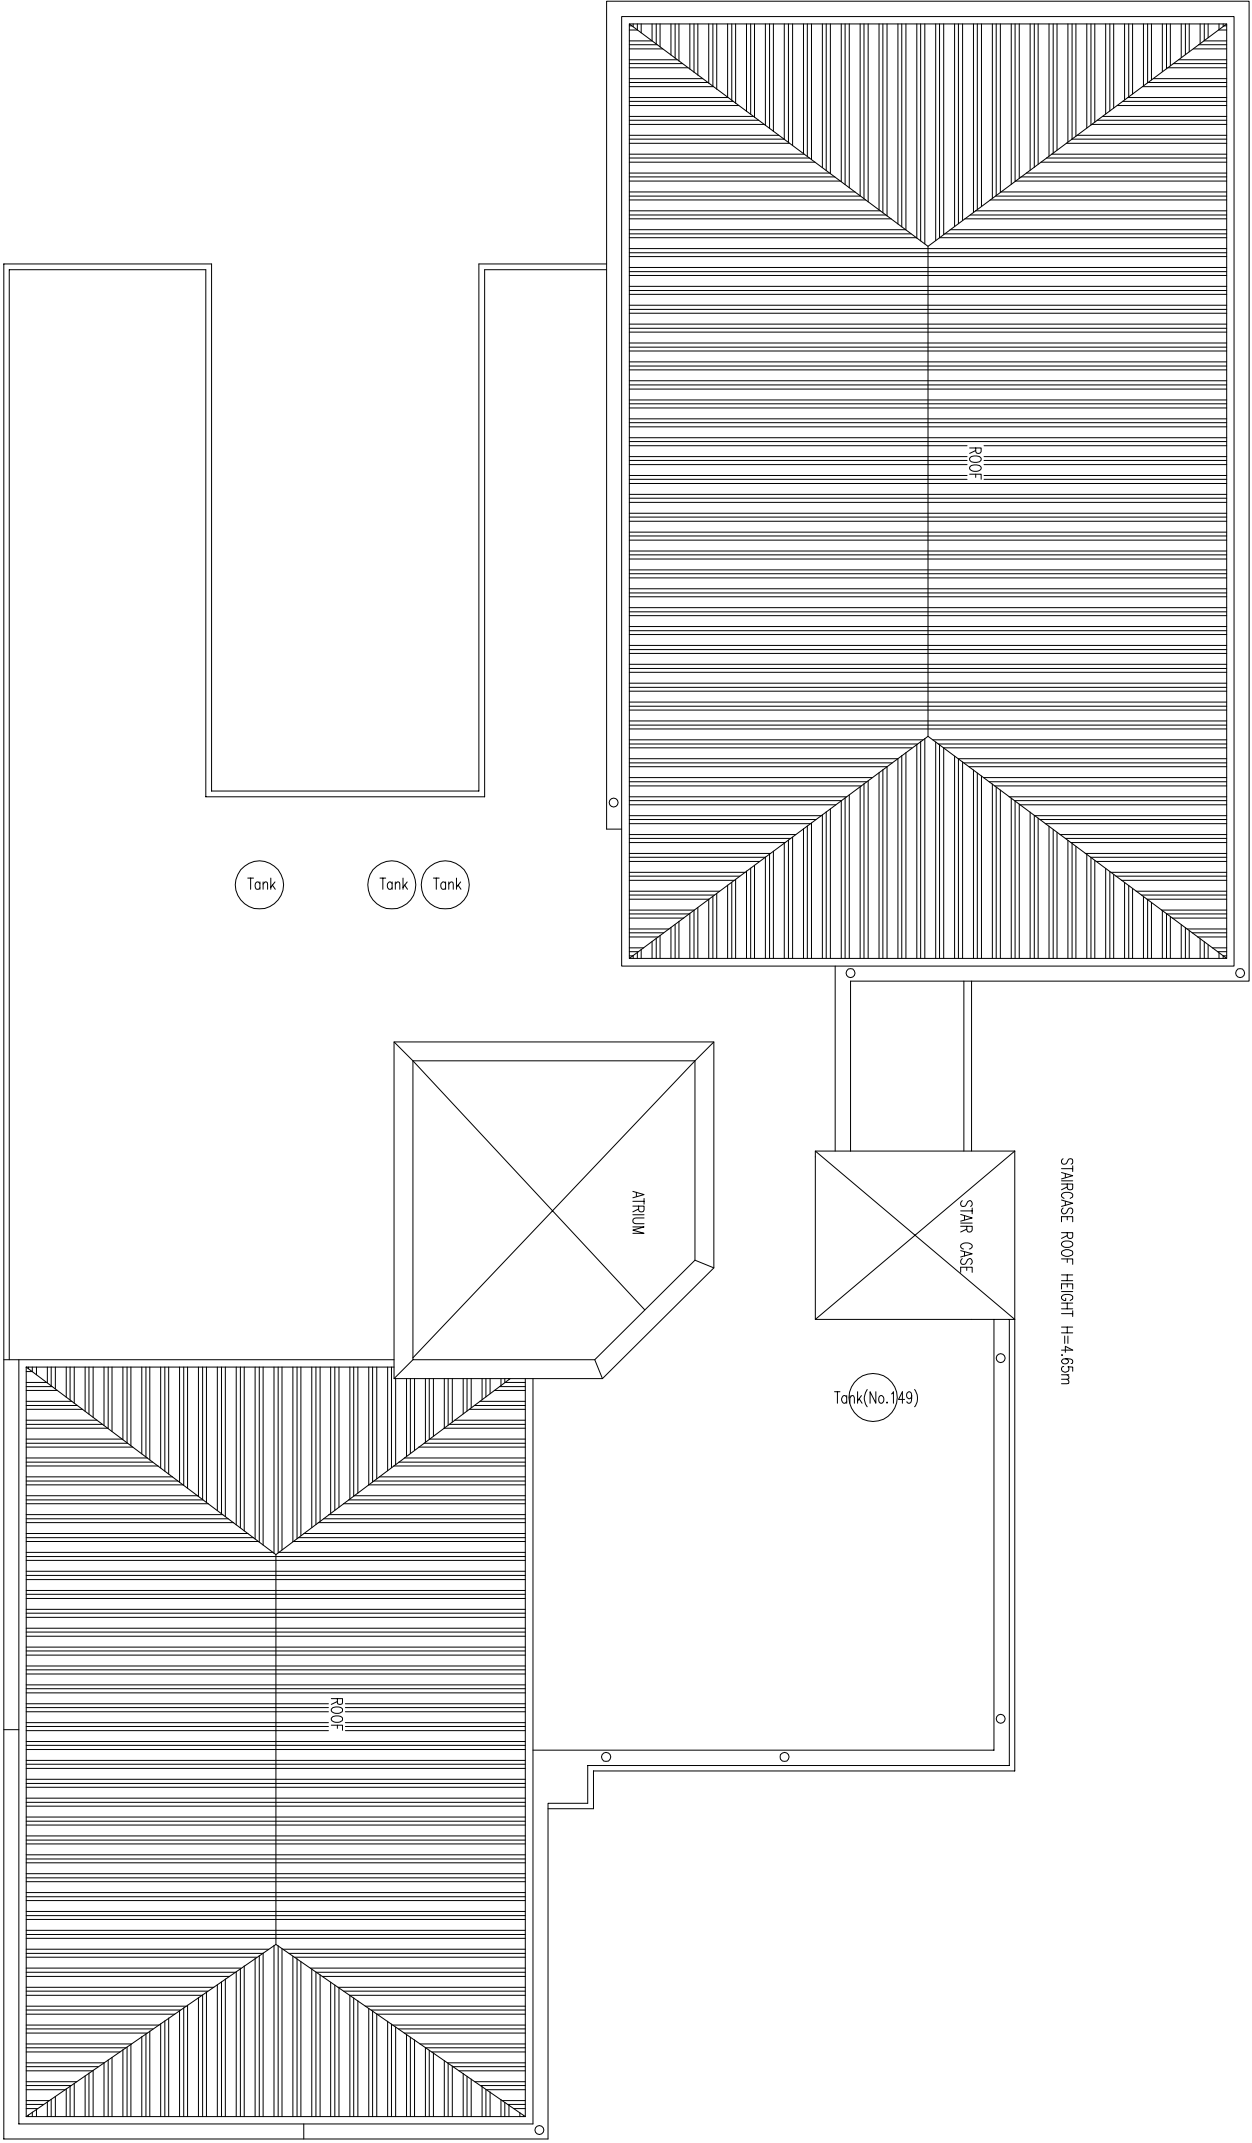 

TERRACE FLOOR PLAN



SCALE 1:200

CONTRACTORS MUST CHECK ALL DIMENSIONS ON SITE BEFORE STARTING ANY WORK OR SHOP DRAWINGS REQUIRED DIMENSIONS TO TAKE FROM ORIGINAL SCALE READINGS

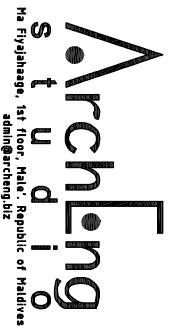


REVISION:	ARCHITECT:	PROJECT:	H.EATHHUGE ALL PROPOSED 07 STOREY BUILDING	DWG NO	A-06
	ENGINEER: MARYAM SAMAH	LOCATION:	K. JUALE	PROJECT NO:	21-001
	ARCHITECTURAL CHECKER:	DRAWING TITLE:	AS GIVEN		
	STRUCTURAL CHECKER:	CLIENT:	MR. ADAM SALEEM		
	DRAWN BY: HAWWA NISWA	SCALE: AS GIVEN	DIMENSION: MM	DATE: SEPTEMBER 2021	

CONCEPT AND DESIGN IN THIS DRAWING ARE THE PROPERTIES OF ARCHENG STUDIO PVT.LTD. UNAUTHORIZED USE OR REPRODUCTION OF PART OF THE DESIGN DRAWINGS OR CONCEPT TO USE IN OTHER PROJECTS OR SITES OTHER THAN SPECIFIED ON THIS DRAWING IS PROHIBITED

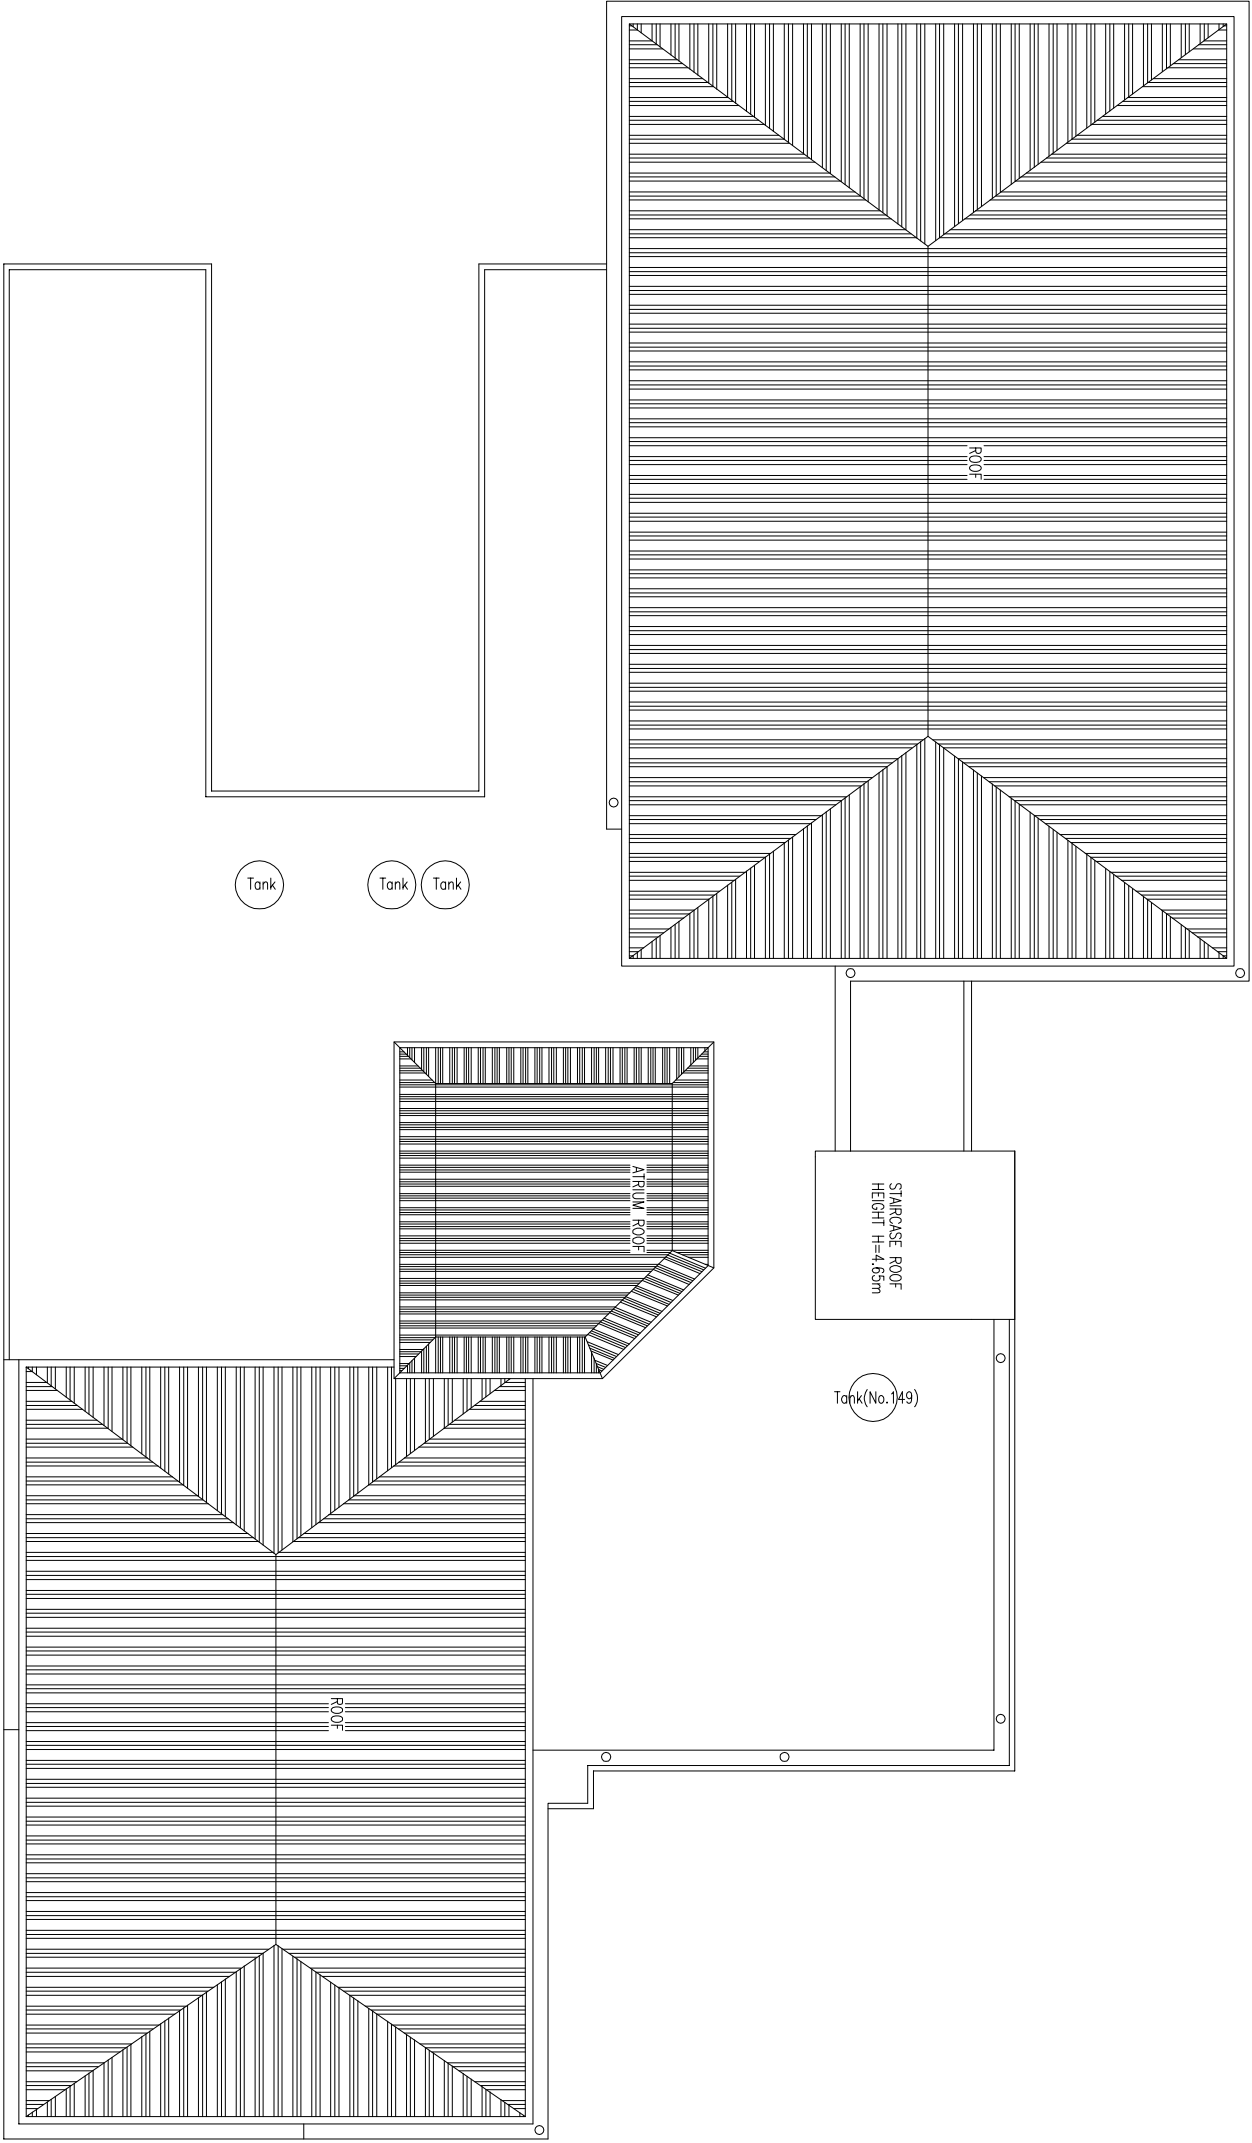 


CONTRACTORS MUST CHECK ALL DIMENSIONS ON SITE BEFORE STARTING ANY WORK OR SHOP DRAWINGS REQUIRED DIMENSIONS TO TAKE FROM DRAWINGS TO TAKE SCALE READINGS

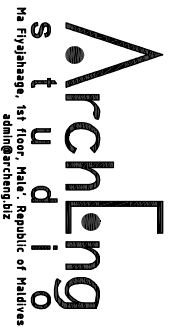

REVISION:	ARCHITECT:	PROJECT:	H.EATHHUGE ALL PROPOSED 07 STOREY BUILDING	DWG NO	A-07
	ENGINEER: MARYAM SAMAH	LOCATION:	K.MALE	PROJECT NO: 21-001	
	ARCHITECTURAL CHECKER:	DRAWING TITLE:	AS GIVEN		
	STRUCTURAL CHECKER:	CLIENT:	MR. ADAM SALEEM		
	DRAWN BY: HAWWA NISWA	SCALE: AS GIVEN	DIMENSION: MM	DATE: SEPTEMBER 2021	

CONCEPT AND DESIGN IN THIS DRAWING ARE THE PROPERTIES OF ARCHENG STUDIO PVT.LTD. UNAUTHORIZED USE OR REPRODUCTION OF PART OF THE DESIGN DRAWINGS OR CONCEPT TO USE IN OTHER PROJECTS OR SITES OTHER THAN SPECIFIED ON THIS DRAWING IS PROHIBITED

ROOF PLAN
SCALE 1:200

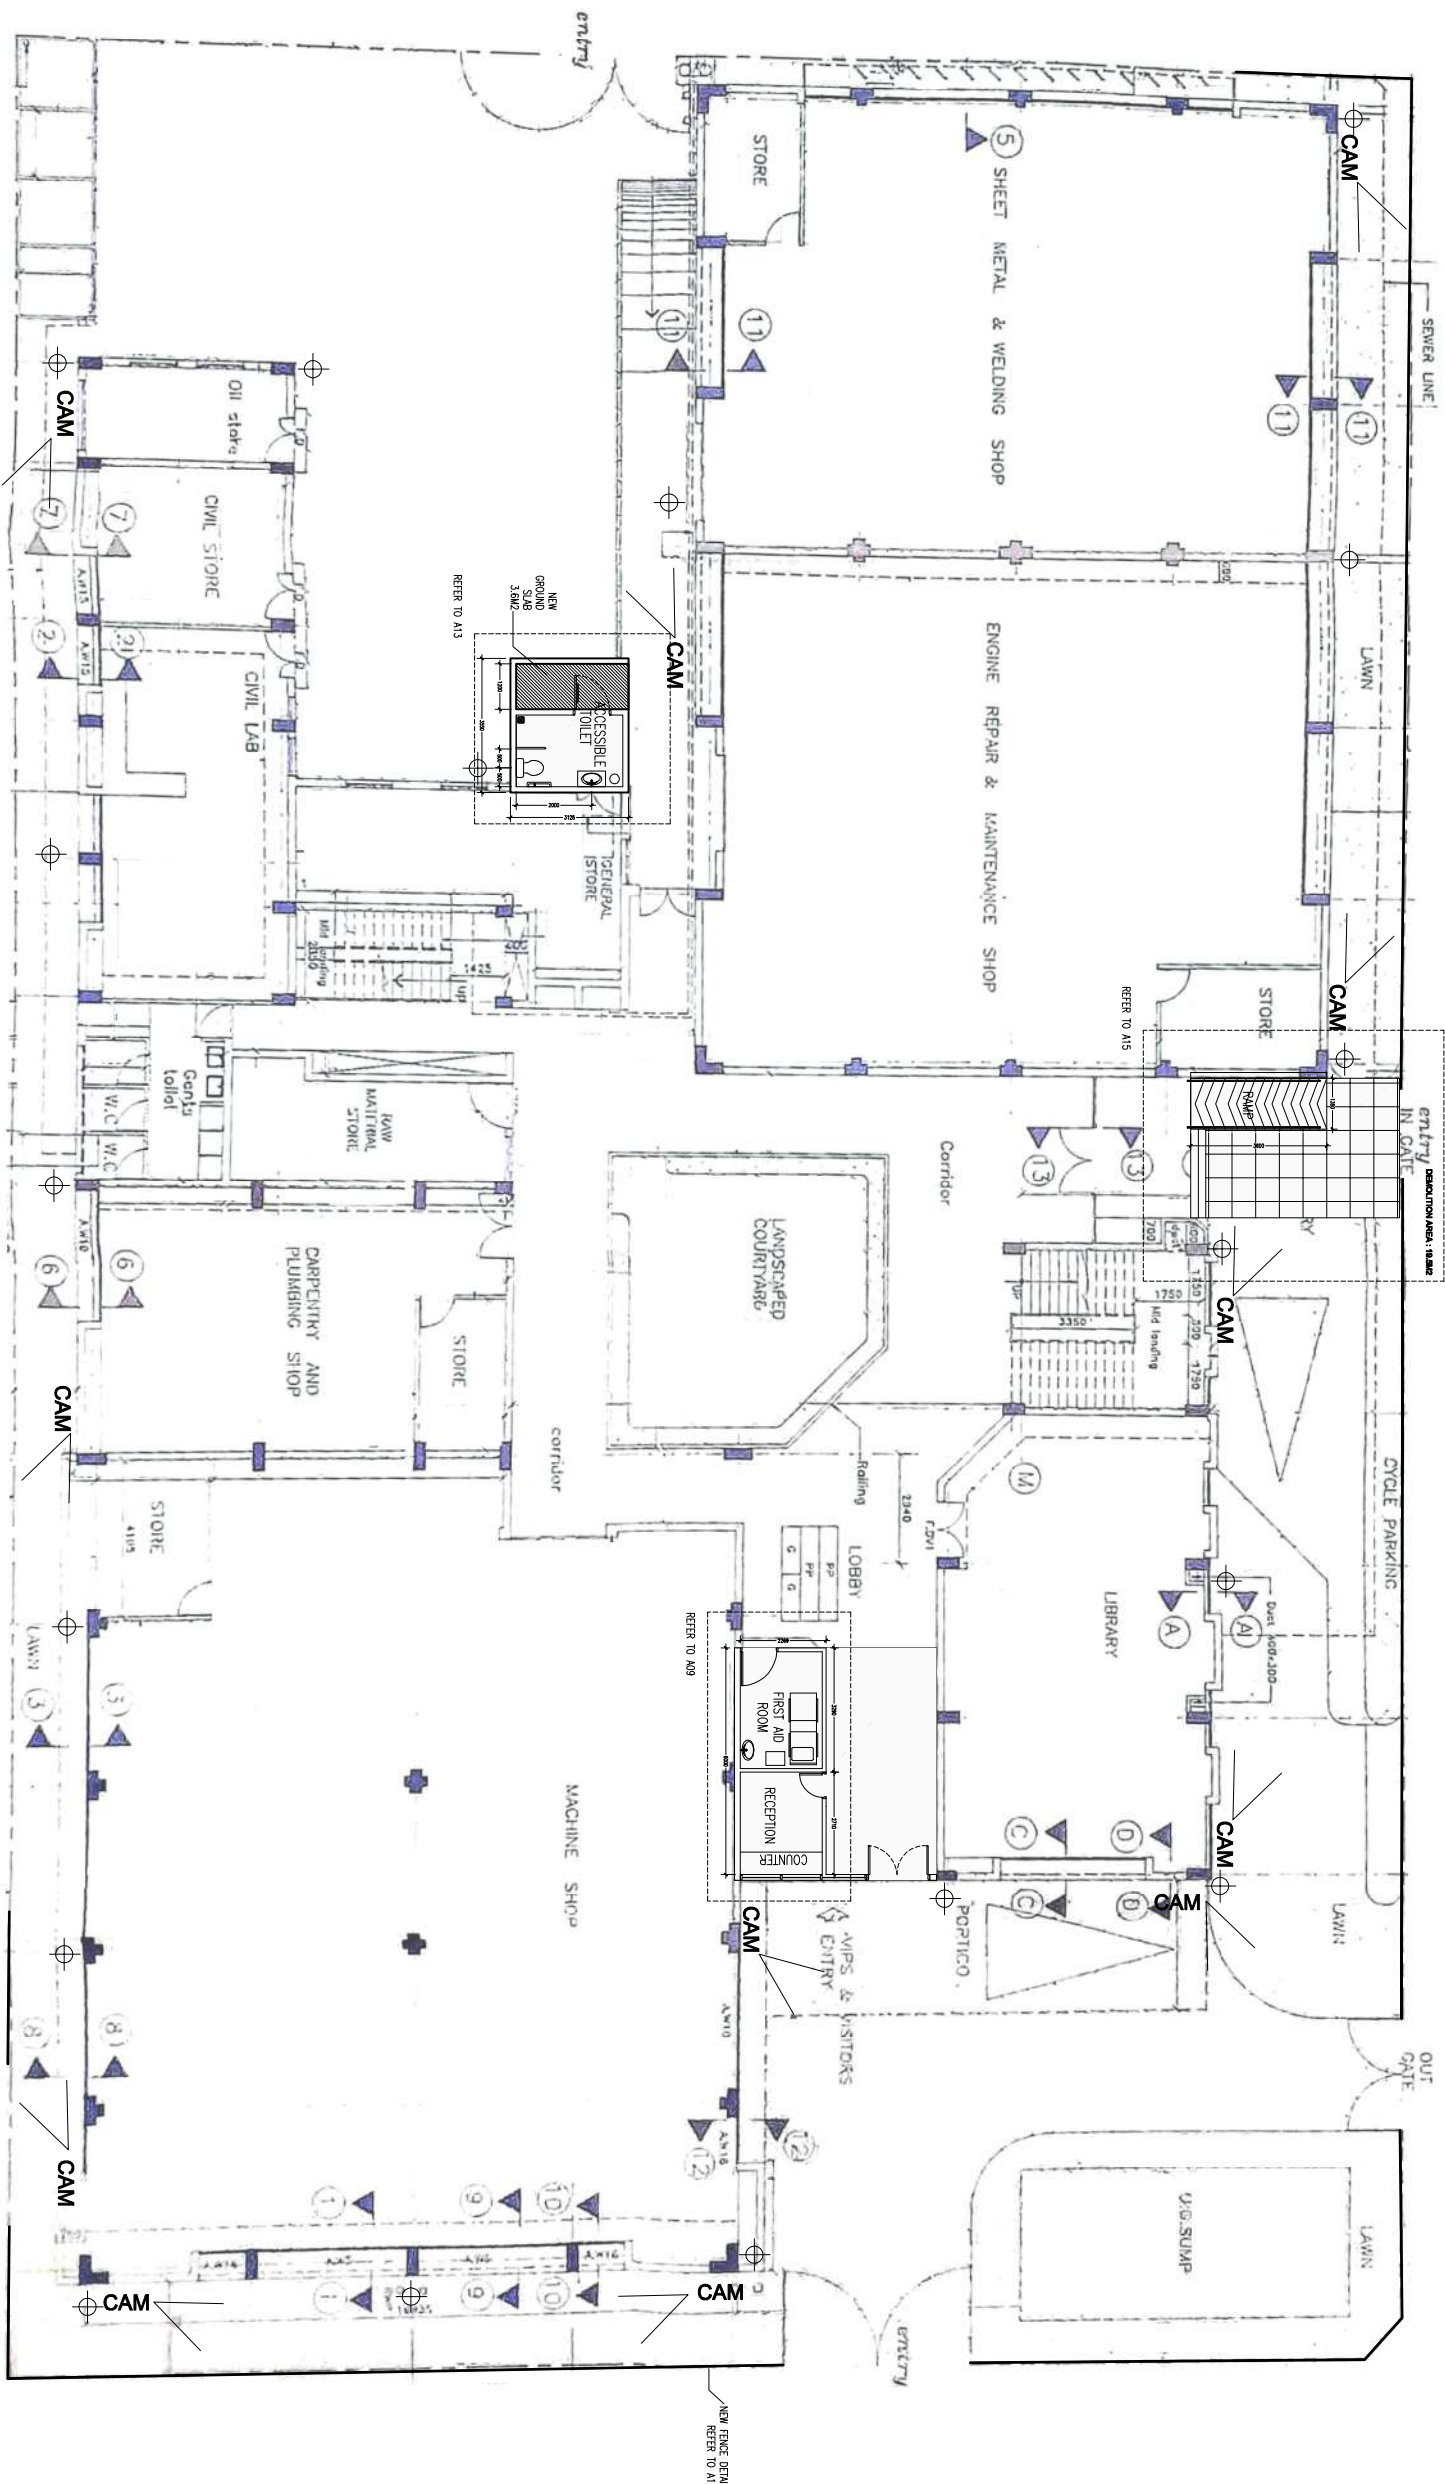

LEGEND

CAM CCTV CAMERA


⊕ SENSOR LIGHTS

— SS FENCE

GROUND FLOOR PLAN-PROPOSED PLAN


SCALE 1:200

CONTRACTORS MUST CHECK ALL DIMENSIONS ON SITE BEFORE STARTING ANY WORK OR SHOP DRAWINGS. FIGURED DIMENSIONS TO TAKE PRECEDENCE OVER SCALE REMAININGS

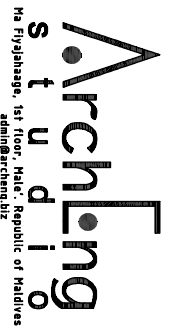


REVISION:	ARCHITECT:	MARYAM SAMAH	PROJECT:	MALDIVES POLYTECHNIC, KUALE CAMPUS	DWG NO	A-08
	ENGINEER:		LOCATION:	KUALE	PROJECT NO:	21-001
	ARCHITECTURAL CHECKER:		DRAWING TITLE:	AS GIVEN		
	STRUCTURAL CHECKER:	HAWWA NISWA	CLIENT:	MINISTRY OF HIGHER EDUCATION		
	DRAWN BY:		SCALE:	AS GIVEN	DIMENSION:	MM
			DATE:	SEPTEMBER 2021		


CONCEPT AND DESIGN IN THIS DRAWING ARE THE PROPERTIES OF ARCHING STUDIO PVT LTD. UNAUTHORIZED USE OR REPRODUCTION OF PART OF THE DESIGN DRAWINGS OR CONCEPT TO USE IN OTHER PROJECTS OR SITES OTHER THAN SPECIFIED ON THIS DRAWING IS PROHIBITED

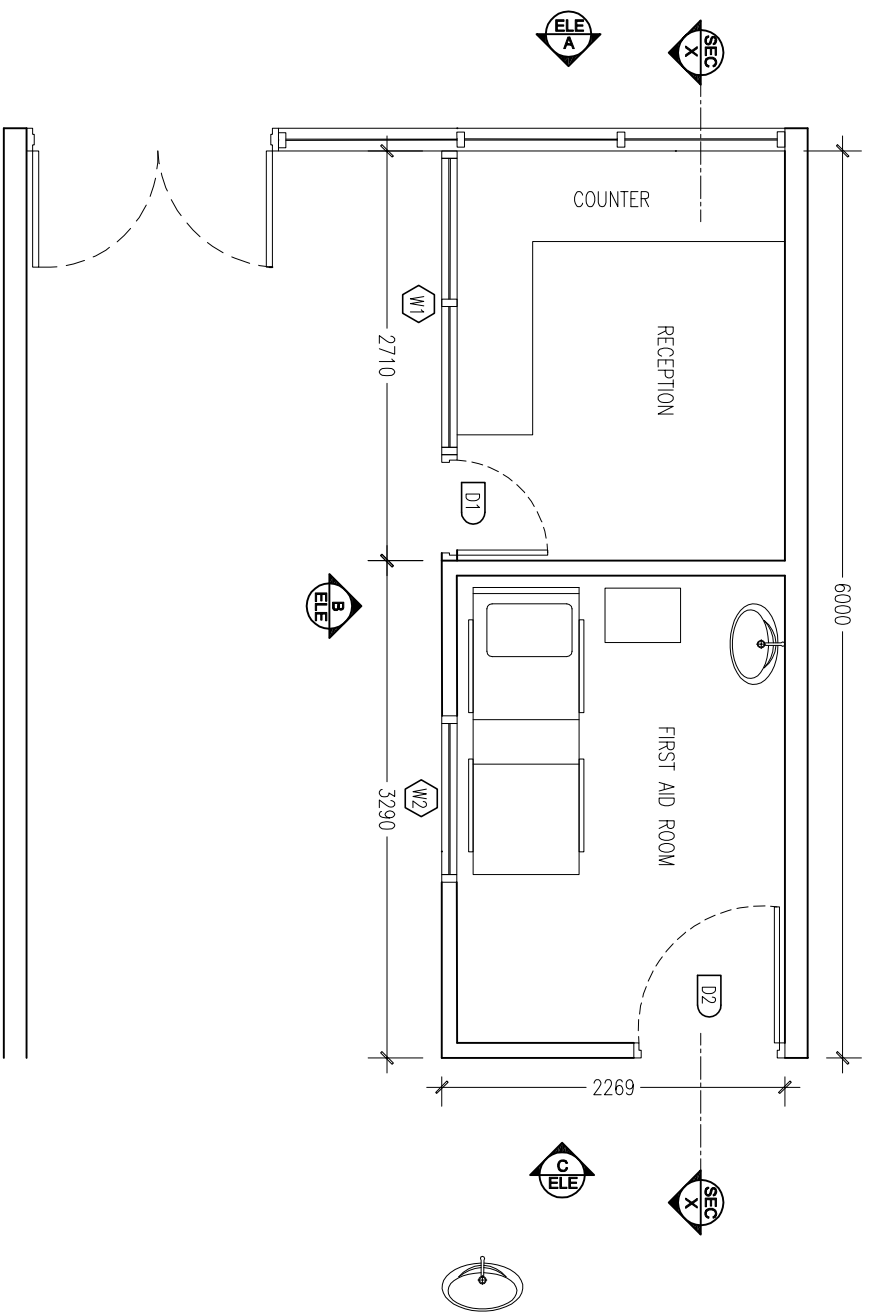


RECEPTION & FIRST AID ROOM PLAN
SCALE 1:50

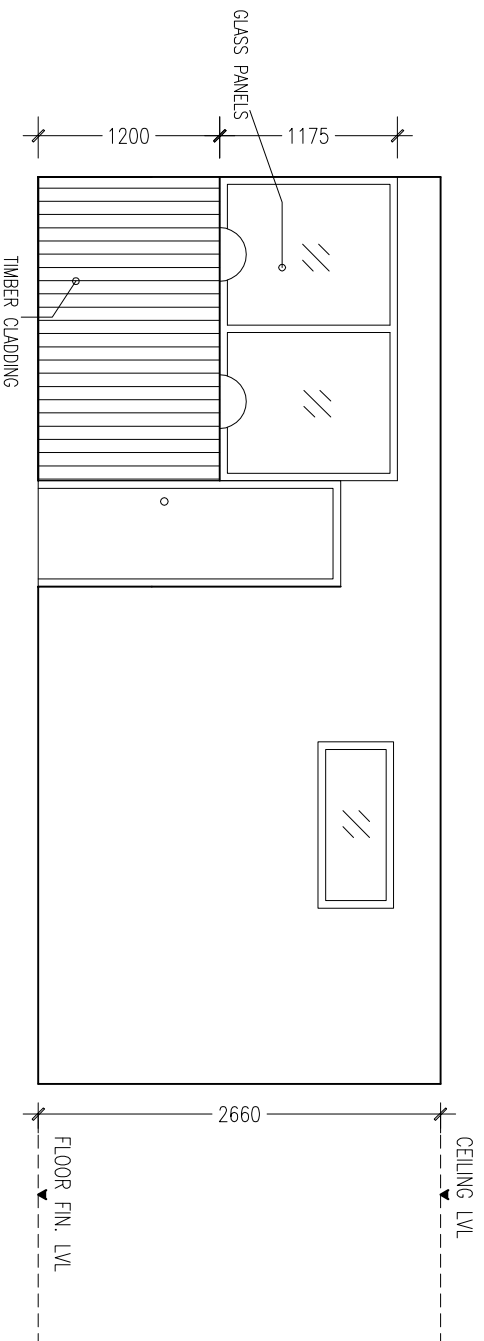


ELEVATION-B
SCALE 1:50

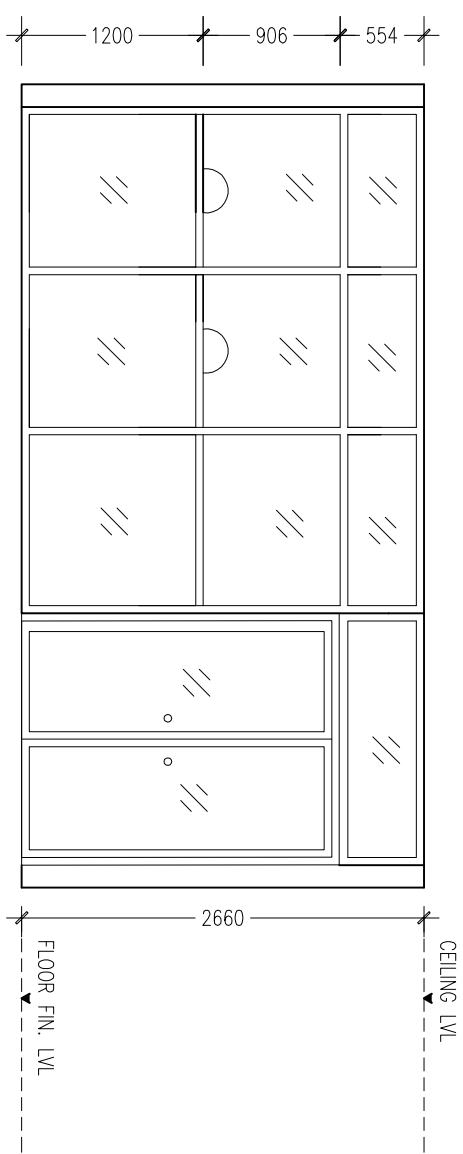

ELEVATION-A
SCALE 1:50

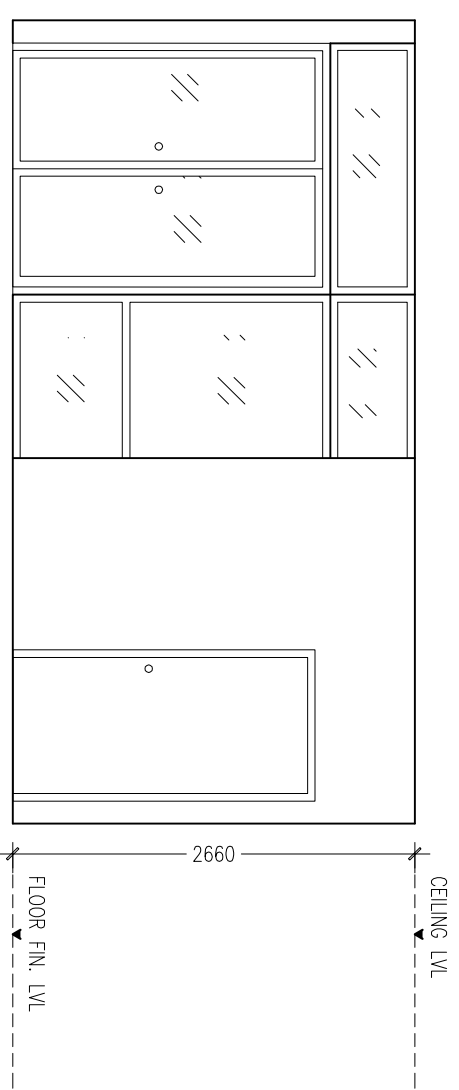


ELEVATION-C
SCALE 1:50

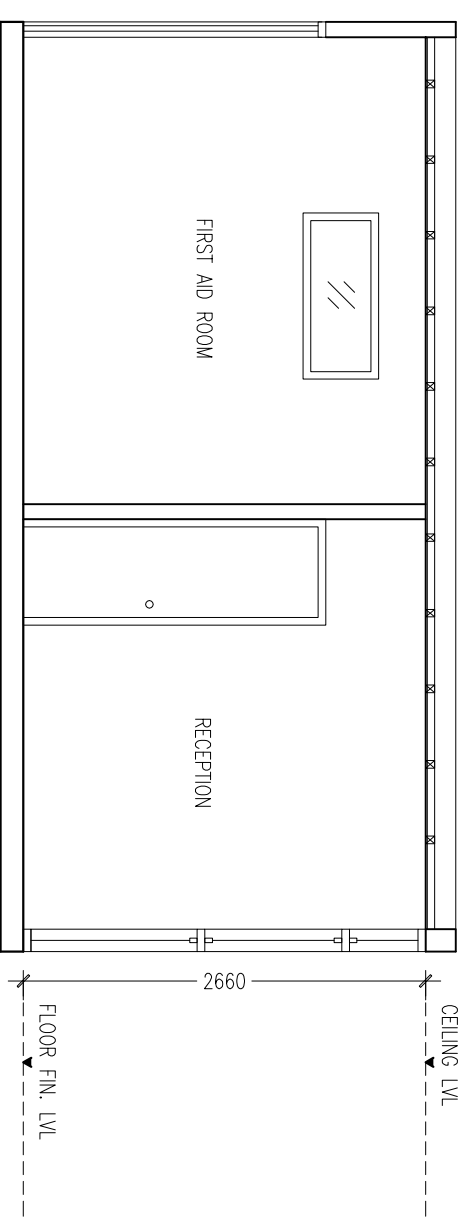

SECTION-X
SCALE 1:50

CONTRACTORS MUST CHECK ALL DIMENSIONS ON SITE BEFORE STARTING ANY WORK OR SHOP DRAWINGS. REQUIRED DIMENSIONS TO TAKE SCALE READINGS

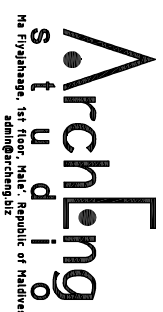

REVISION:	ARCHITECT:	PROJECT:	MALDIVES POLYTECHNIC, KMALE CAMPUS
	ENGINEER:	LOCATION:	KMALE
	ARCHITECTURAL CHECKER:	DRAWING TITLE:	AS GIVEN
	STRUCTURAL CHECKER:	CLIENT:	MINISTRY OF HIGHER EDUCATION
	DRAWN BY:	SCALE:	AS GIVEN
	HAWWA NISWA	DIMENSION:	MM
		DATE:	SEPTEMBER 2021
		PROJECT NO.:	21-001
		DWG NO.	A-09

CONCEPT AND DESIGN IN THIS DRAWING ARE THE PROPERTIES OF ARCHENG STUDIO PVT LTD. UNAUTHORIZED USE OR REPRODUCTION OF PART OF THE DESIGN/DRAWINGS OR CONCEPT TO USE IN OTHER PROJECTS OR SITES OTHER THAN SPECIFIED ON THIS DRAWING IS PROHIBITED

ELEVATIONS :					
FINISH FLOOR LEVEL					
DR / WD NO.	D1	D2	W1	W2	COMMON ROOM DOOR
DESCRIPTION :	40MM THICK OPENABLE ALUMINIUM DOOR PANEL	40MM THICK OPENABLE ALUMINIUM DOOR PANEL	ALUMINIUM FRAMED FIXED WINDOW PANELS	ALUMINIUM FRAMED FIXED WINDOW PANELS	40MM THICK OPENABLE ALUMINIUM DOOR PANEL
FRAME :	40 MICRON WHITE POWDER COATED ALUMINIUM FRAME	40 MICRON WHITE POWDER COATED ALUMINIUM FRAME	80 MICRON WHITE POWDER COATED ALUMINIUM FRAME	80 MICRON WHITE POWDER COATED ALUMINIUM FRAME	40 MICRON WHITE POWDER COATED ALUMINIUM FRAME
HARDWARE :	DOOR CLOSER CYLINDRICAL LOCK BUTT HINGE STOPPER HOLDER	DOOR CLOSER CYLINDRICAL LOCK BUTT HINGE STOPPER HOLDER			DOOR CLOSER CYLINDRICAL LOCK BUTT HINGE STOPPER HOLDER
GLAZING :	C-4MM	C-4MM			6MM THICK CLEAR GLASS

NOTE :
G-GLASS
FG-FIXED GLASS

PROPOSED DOOR/WINDOW SCHEDULE

SCALE 1:50


CONTRACTORS MUST CHECK ALL DIMENSIONS ON SITE BEFORE STARTING ANY WORK OR SHOP DRAWINGS. REQUIRED DIMENSIONS TO TAKE SCALE READINGS

ArchLeng
s t u d i o
1st Floor, Nade, Republic of Maldives
Zamindhar Street

REVISION:	ARCHITECT:	PROJECT:	MALDIVES POLYTECHNIC, KUMALE CAMPUS
	ENGINEER: MARIYAM SAMAH	LOCATION:	KUMALE
	ARCHITECTURAL CHECKER:	DRAWING TITLE:	AS GIVEN
	STRUCTURAL CHECKER:	CLIENT:	MINISTRY OF HIGHER EDUCATION
	DRAWN BY: HAWWA NISWA	SCALE: AS GIVEN	DIMENSION: MM
		DATE: SEPTEMBER 2021	
			PROJECT NO.: 21-001

A-10

CONCEPT AND DESIGN IN THIS DRAWING ARE THE PROPERTIES OF ARCHENG STUDIO PVT LTD. UNAUTHORIZED USE OR REPRODUCTION OF PART OF THE DESIGN/DRAWINGS OR CONCEPT TO USE IN OTHER PROJECTS OR SITES OTHER THAN SPECIFIED ON THIS DRAWING IS PROHIBITED

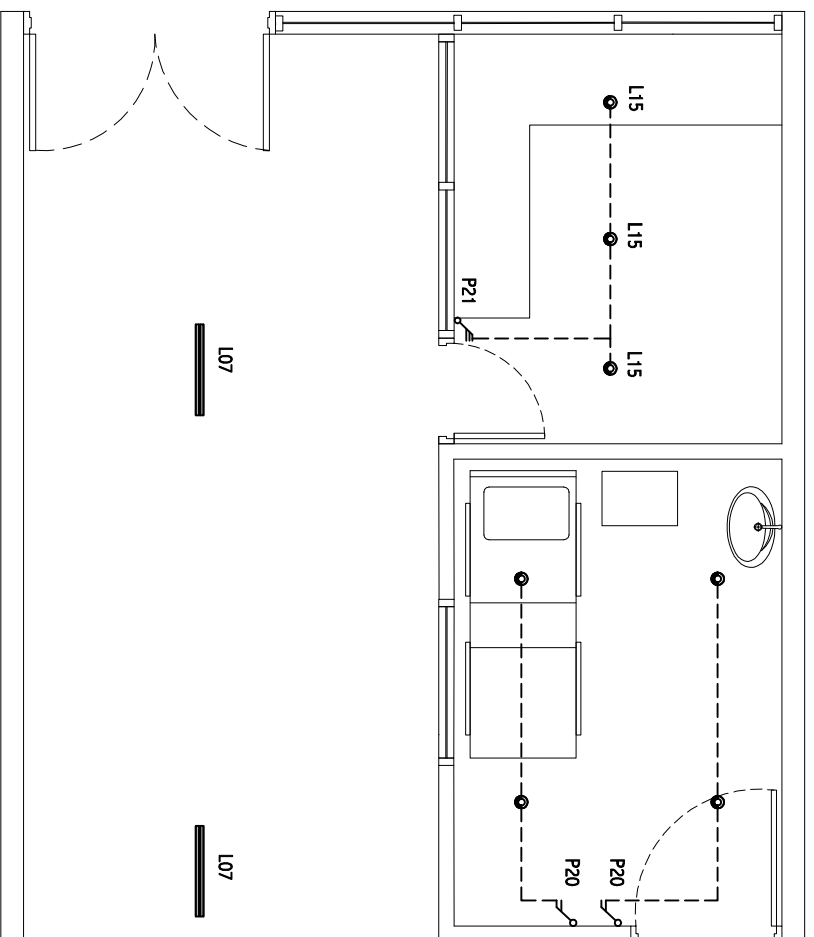

RECEPTION/FIRST AID ROOM LIGHTING LAUOUT PLAN
SCALE 1:50


LIGHTING LEGEND

●	L15	1X16W ENERGY SAVING SLAB MOUNT WARM COMPACT FLUORESCENT LAMPS IN RECESSED DECORATIVE LUMINAIRE
▬	L07	2X36W FLUORESCENT LAMPS IN SURFACE MOUNT LUMINAIRE WITH DIFFUSER

2X36W FLUORESCENT LAMPS IN SURFACE MOUNT LUMINAIRE WITH DIFFUSER

SWITCHES LEGEND

☐	P20	2GANG 1 WAY SWITCH
☐	P21	3GANG 1 WAY SWITCH

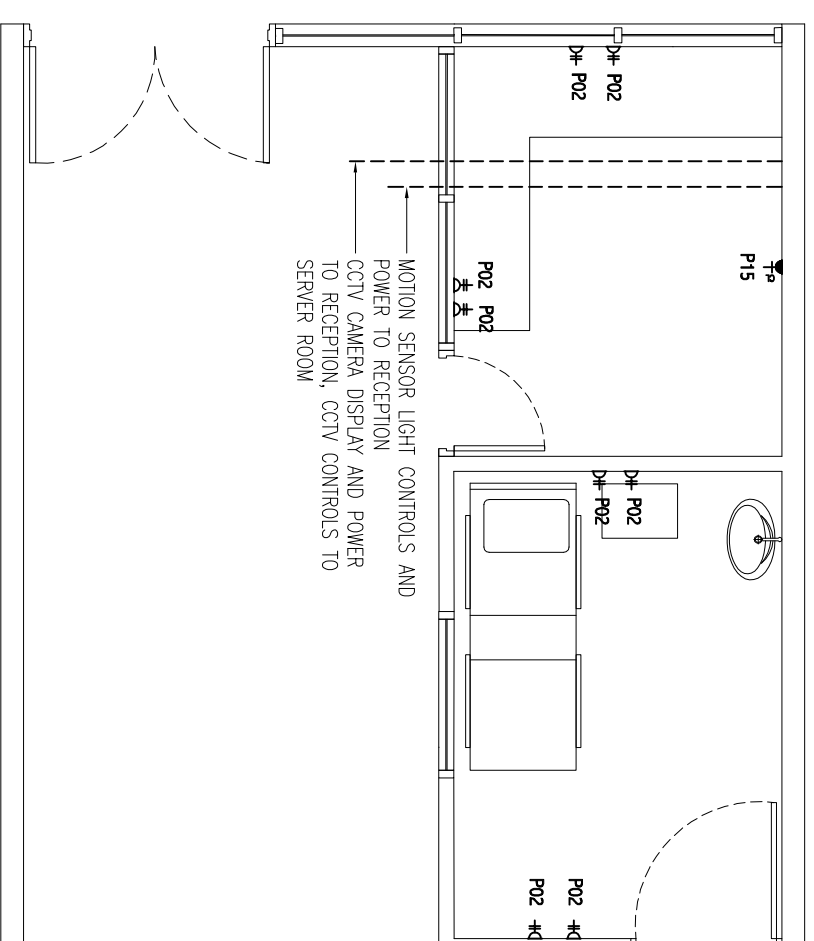


RECEPTION/FIRST AID ROOM SOCKET LAUOUT PLAN
SCALE 1:50

ELECTRICAL LEGEND

SYMBOL	CODE	DESCRIPTION
☐	P02	2GANG 13A SOCKET OUTLET AT 300mm ABOVE FINISHED FLOOR LEVEL
☐	P15	1 GANG 15A SOCKET OUTLET AT CEILING LEVEL

CONTRACTORS MUST CHECK ALL DIMENSIONS ON SITE BEFORE STARTING ANY WORK OR SHOP DRAWINGS. REQUIRED DIMENSIONS TO TAKE SCALE READINGS


REVISION:	ARCHITECT:	PROJECT:	MALDIVES POLYTECHNIC, KUMALE CAMPUS
	ENGINEER:	LOCATION:	KUMALE
	ARCHITECTURAL CHECKER:	DRAWING TITLE:	AS GIVEN
	STRUCTURAL CHECKER:	CLIENT:	MINISTRY OF HIGHER EDUCATION
	DRAWN BY:	SCALE:	AS GIVEN
		DIMENSION:	MM
		DATE:	SEPTEMBER 2021
		PROJECT NO.:	21-001

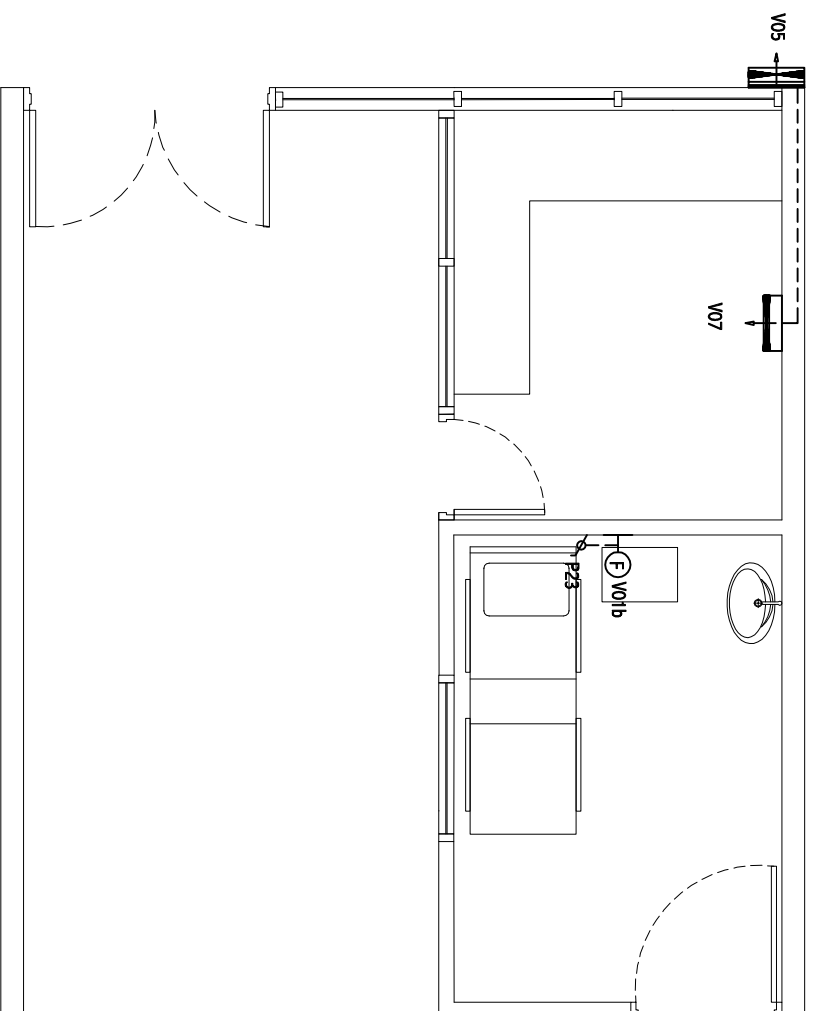

RECEPTION/FIRST AID ROOM FAN/AC LAUOUT PLAN
SCALE 1:50

LEGEND


SYMBOL	CODE	DESCRIPTION
	V01b	WALL MOUNT FAN
	P23	FAN DIMMER SWITCH
	P05	AIR-CONDITIONING OUTDOOR UNIT WALL MOUNTED
	P07	AIR-CONDITIONING INDOOR UNIT WALL MOUNTED

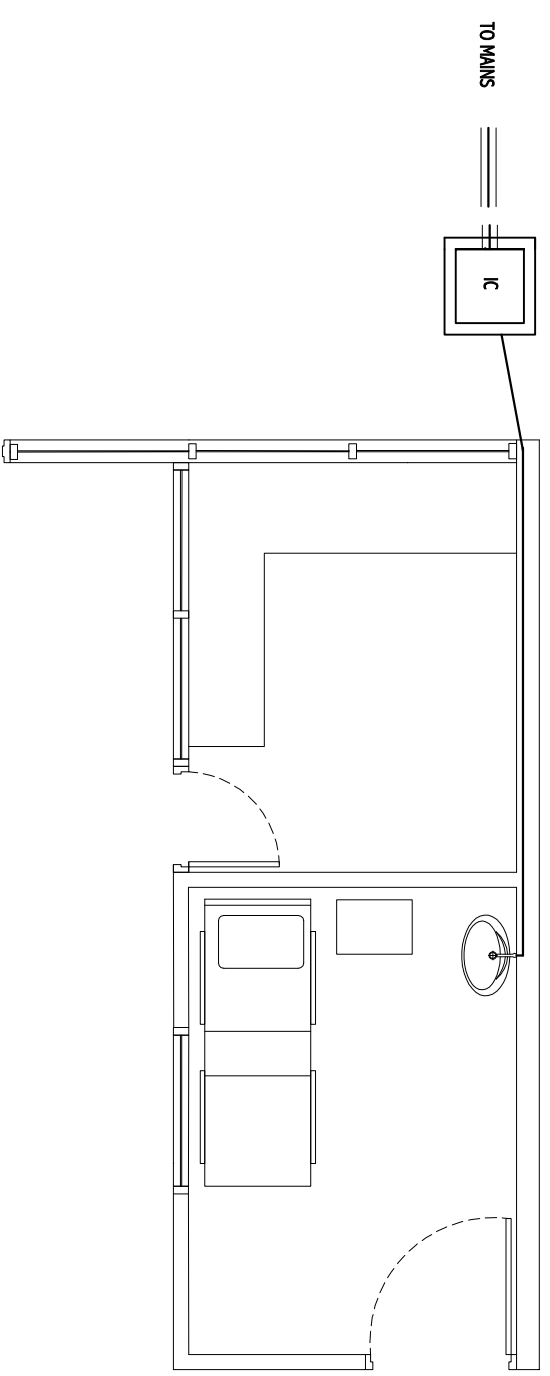

FIRST AID ROOM SEWAGE & WASTE DISPOSAL PLAN
SCALE 1:50


LEGEND

SYMBOL	DESCRIPTION
	TAP
	WATER SUPPLY (Ø12-Ø35)
	UPVC HIGH PRESSURE WASTE WATER PIPE (Ø75-Ø100)
	INSPECTION CHAMBER

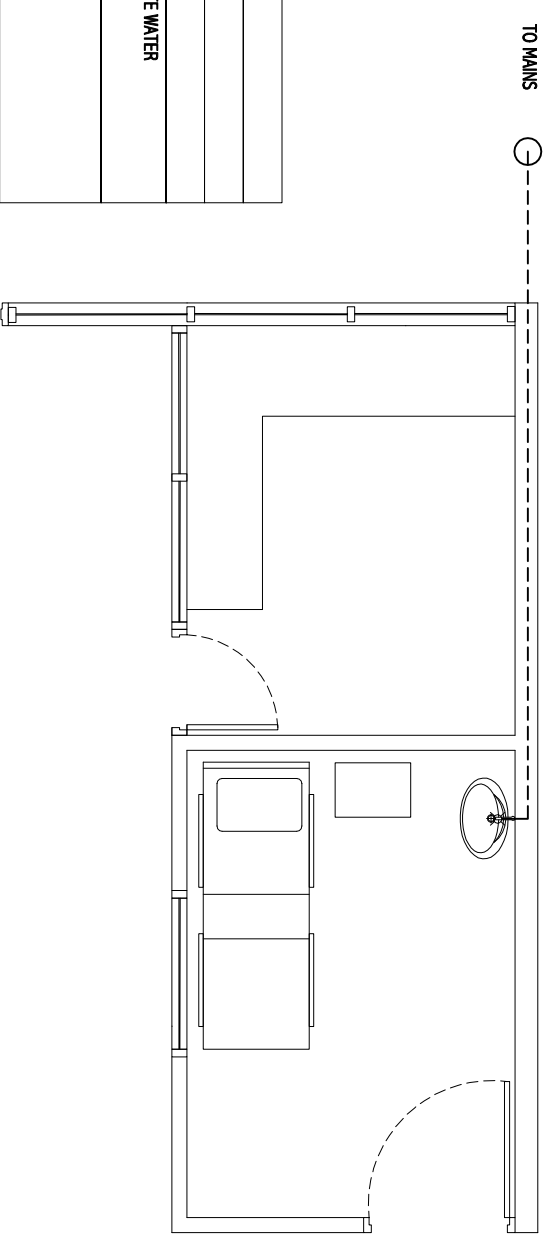


FIRST AID ROOM SEWAGE & WASTE DISPOSAL PLAN
SCALE 1:50


CONTRACTORS MUST CHECK ALL DIMENSIONS ON SITE BEFORE STARTING ANY WORK OR SHOP DRAWINGS. REQUIRED DIMENSIONS TO TAKE SCALE READINGS

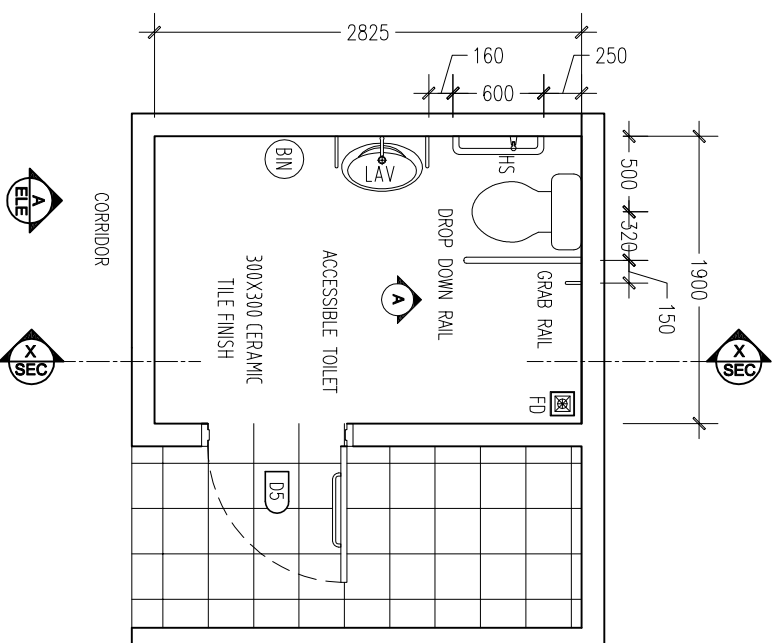


ACCESSIBLE TOILET FLOOR PLAN
SCALE 1:50

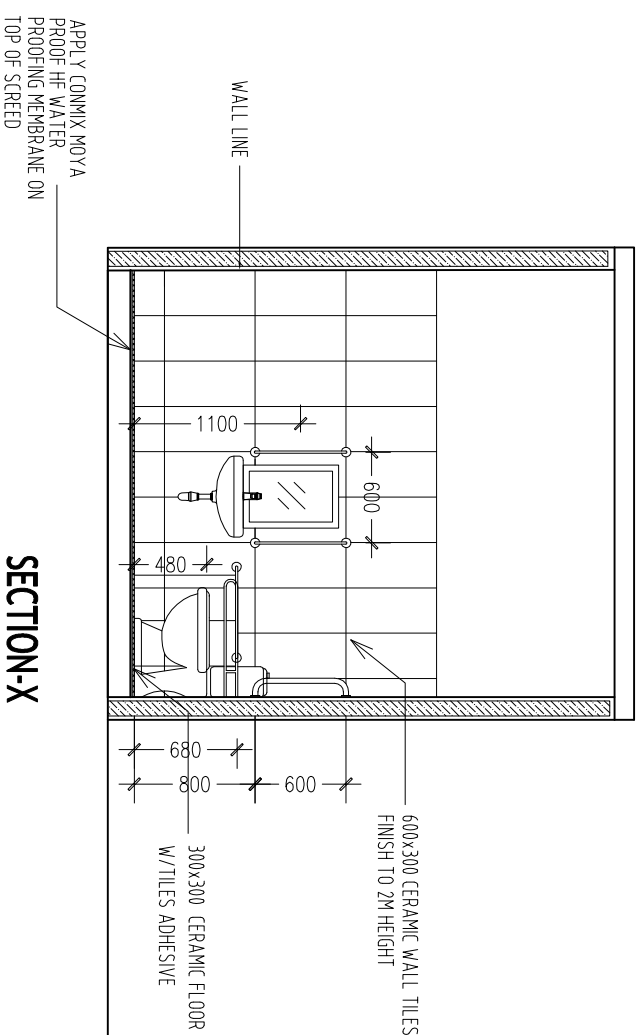


SECTION-X
SCALE 1:50

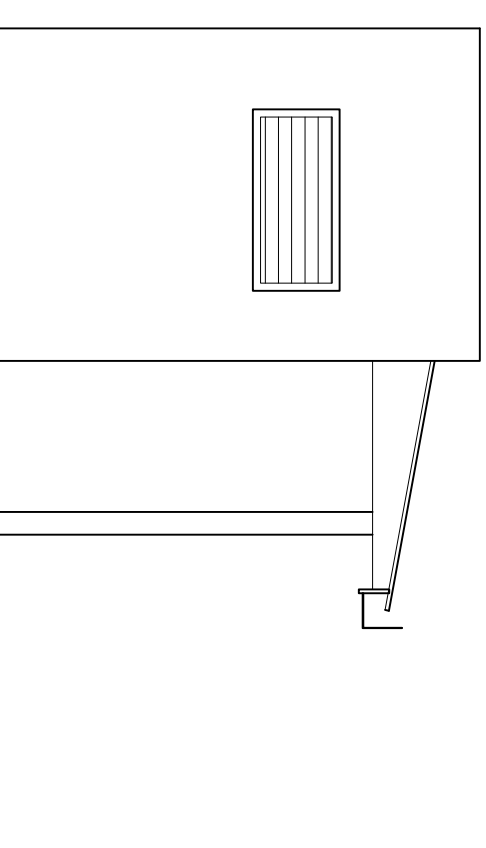

ELEVATION-A
SCALE 1:50

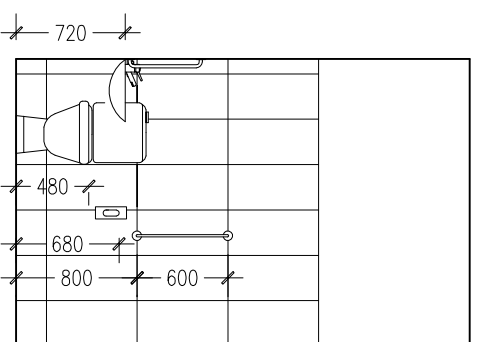

INTERIOR ELEVATION-A
SCALE 1:50

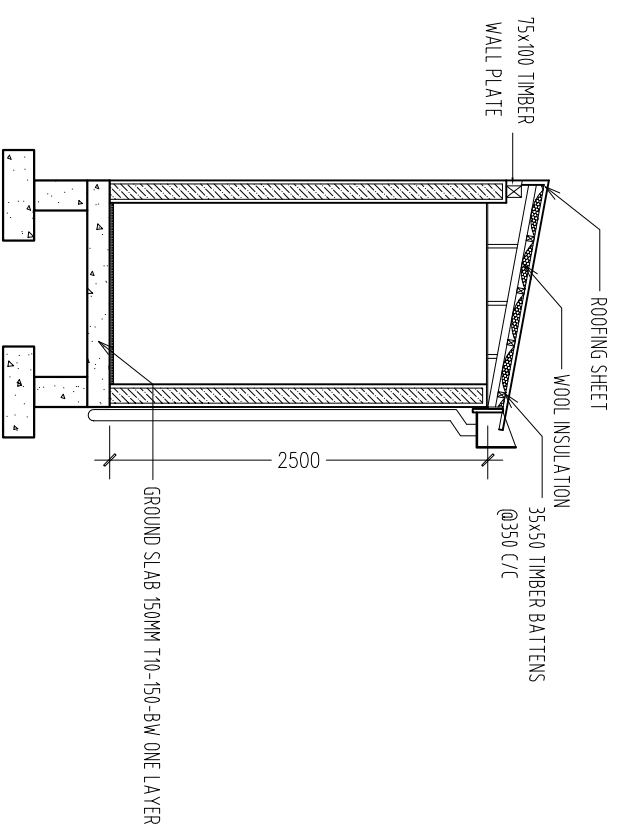


ROOF DETAIL
SCALE 1:50

ELEVATIONS :	
FINISH FLOOR LEVEL	2300
DR / WD NO.	D1
DESCRIPTION :	40MM THICK OPENABLE SOLID TIMBER DOOR PANEL
FRAME :	120MM TIMBER FRAME
HARDWARE :	DOOR CLOSER CYLINDRICAL LOCK BUTT HINGE STOPPER HOLDER
GLAZING :	-

NOTE :
ALL TOILETS TO BE MECHANICALLY VENTILATED

PROPOSED DOOR SCHEDULE
SCALE 1:50

CONTRACTORS MUST CHECK ALL DIMENSIONS ON SITE BEFORE STARTING ANY WORK OR SHOP DRAWINGS. REQUIRED DIMENSIONS TO TAKE SCALE READINGS

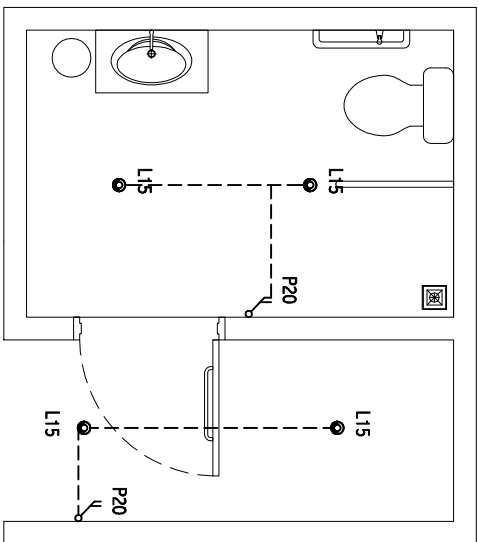


ACCESSIBLE TOILET LIGHTING LAYOUT PLAN
SCALE 1:50

LIGHTING LEGEND

●	L15	1X16W ENERGY SAVING SLAB MOUNT WARM COMPACT FLUORESCENT LAMPS IN RECESSED DECORATIVE LUMINAIRE
---	-----	--

SWITCHES LEGEND

⎓	P20	2GANG 1 WAY SWITCH
---	-----	--------------------

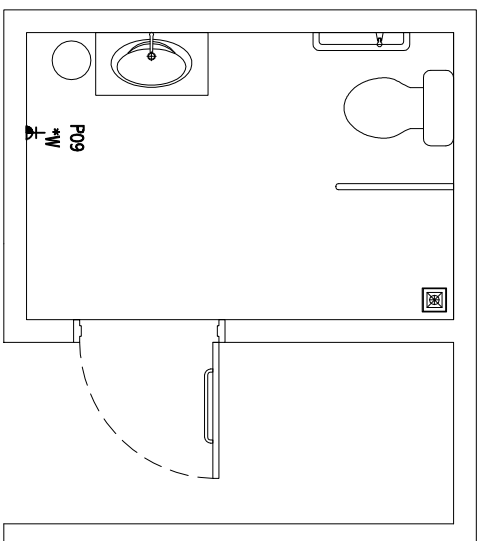

ACCESSIBLE TOILET SOCKET LAYOUT PLAN
SCALE 1:50


ELECTRICAL LEGEND

SYMBOL	CODE	DESCRIPTION
⎓	P09	1 GANG 3A SOCKET OUTLET AT 1200mm ABOVE FINISHED FLOOR LEVEL


*SOCKET INSTALLED INSIDE WEATHER PROOF COVER

LEGEND

SYMBOL	DESCRIPTION
⎓	TAP
⤴	MUSLIM SHOWER
---	WATER SUPPLY (Ø12-Ø35)
⊠	FLOOR DRAIN
—	UPVC HIGH PRESSURE WASTE WATER PIPE (Ø75-Ø100)
≡≡≡	SEWAGE DISPOSAL (Ø100-Ø150)
IC	INSPECTION CHAMBER

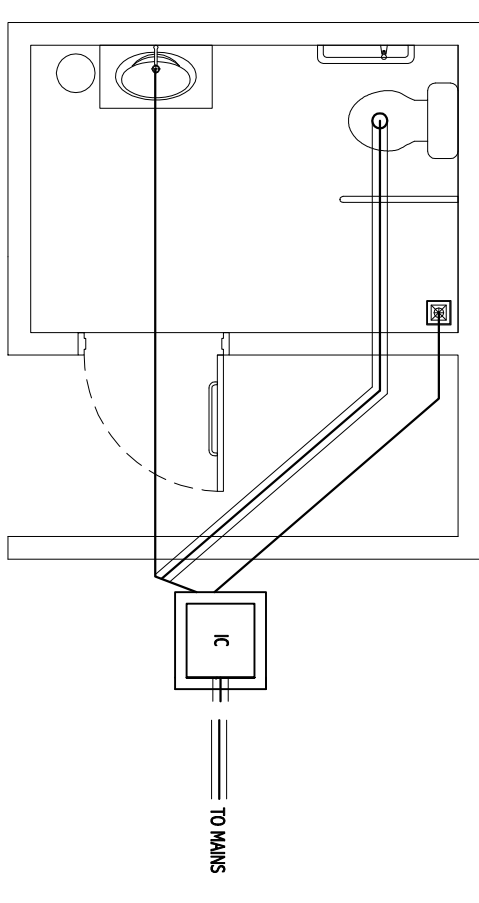


ACCESSIBLE TOILET SEWAGE & WASTE DISPOSAL PLAN
SCALE 1:50

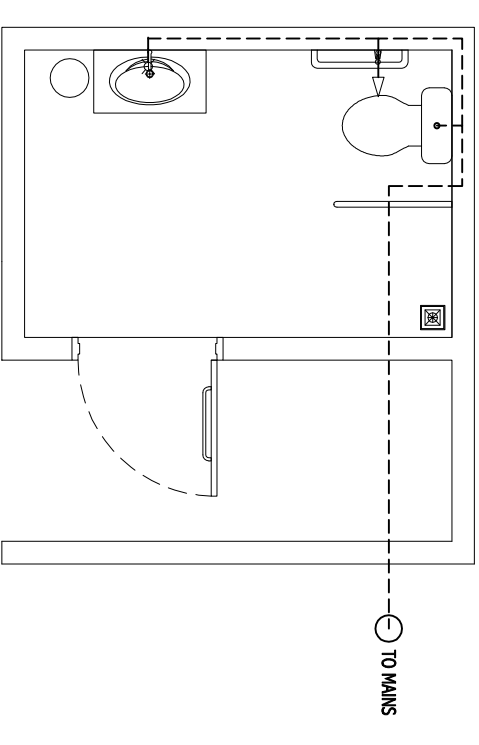

ACCESSIBLE TOILET FRESH WATER SUPPLY PLAN
SCALE 1:50

CONTRACTORS MUST CHECK ALL DIMENSIONS ON SITE BEFORE STARTING ANY WORK OR SHOP DRAWINGS. REQUIRED DIMENSIONS TO TAKE SCALE READINGS

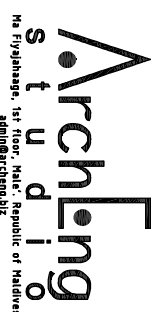


Archling Studio, 1st Floor, Nani, Republic of Maldives
S t u d i o

REVISION:	ARCHITECT:	PROJECT:	MALDIVES POLYTECHNIC, KUMALE CAMPUS
	ENGINEER: MARIYAM SAMAH	LOCATION:	KUMALE
	ARCHITECTURAL CHECKER:	DRAWING TITLE:	AS GIVEN
	STRUCTURAL CHECKER:	CLIENT:	MINISTRY OF HIGHER EDUCATION
	DRAWN BY: HAWVA NISVA	SCALE: AS GIVEN	DIMENSION: MM
		DATE: SEPTEMBER 2021	PROJECT NO.: 21-001


A-14

PROJECT NO.: 21-001

CONCEPT AND DESIGN IN THIS DRAWING ARE THE PROPERTIES OF ARCHING STUDIO PVT LTD. UNAUTHORIZED USE OR REPRODUCTION OF PART OF THE DRAWINGS OR CONCEPT TO USE IN OTHER PROJECTS OR SITES OTHER THAN SPECIFIED ON THIS DRAWING IS PROHIBITED

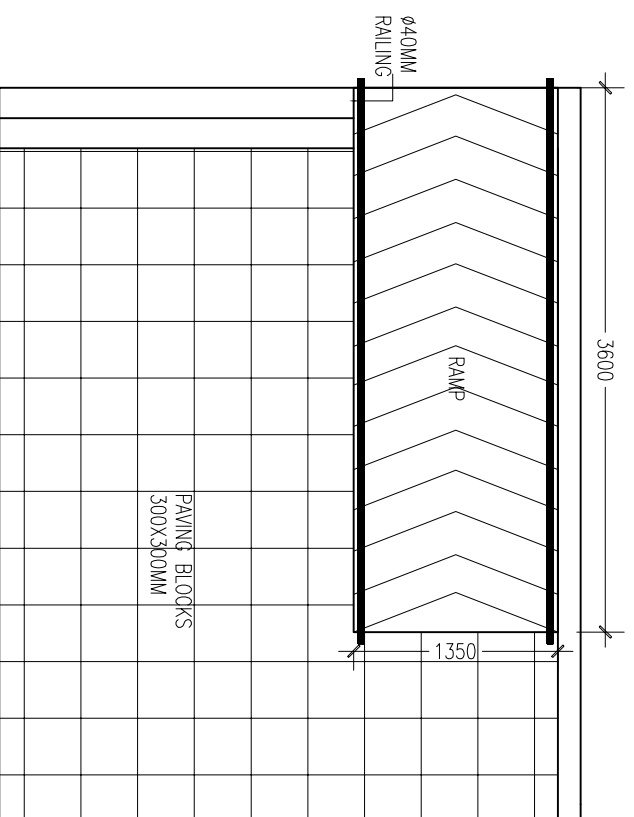


PROPOSED RAMP
SCALE 1:50

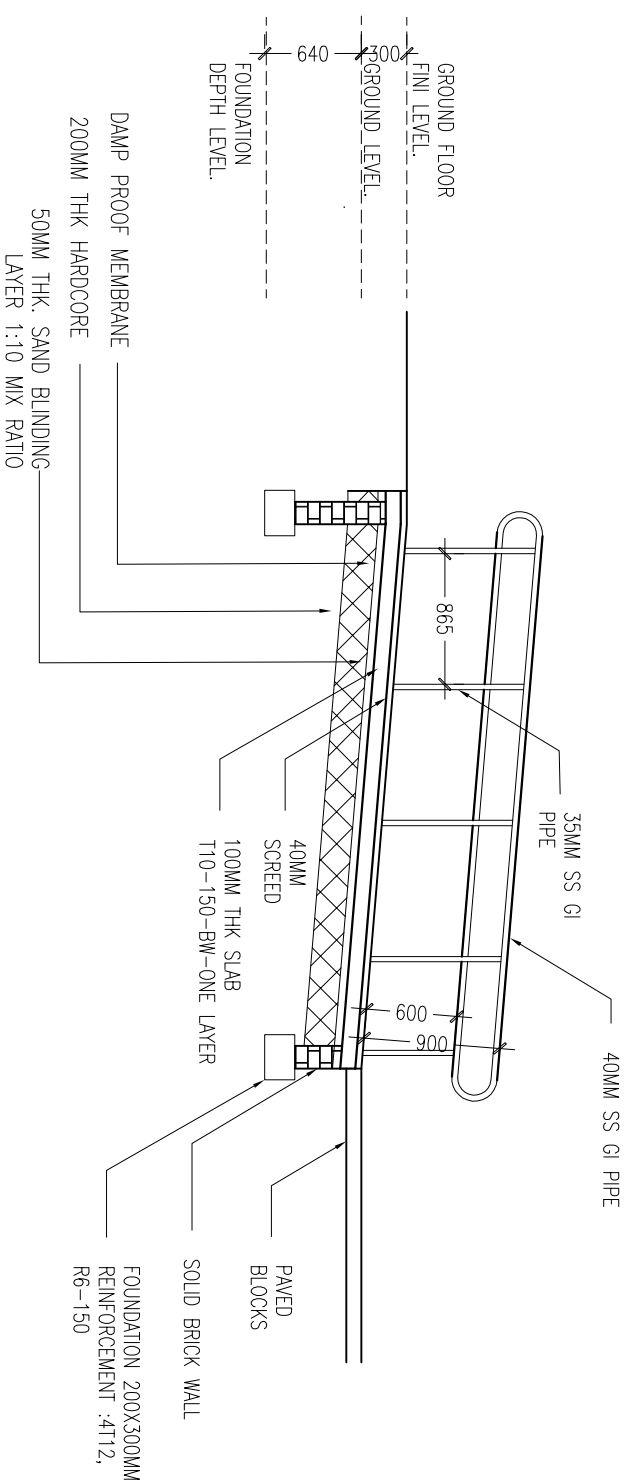

RAMP DETAIL
SCALE 1:50


CONTRACTORS MUST CHECK ALL DIMENSIONS ON SITE BEFORE STARTING ANY WORK OR SHOP DRAWINGS. REQUIRED DIMENSIONS TO TAKE SCALE READINGS

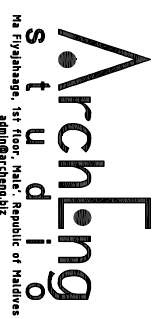


REVISION:	ARCHITECT:	PROJECT:	MALDIVES POLYTECHNIC, KUMALE CAMPUS
	ENGINEER: MARIYAM SAMAH	LOCATION:	KUMALE
	ARCHITECTURAL CHECKER:	DRAWING TITLE:	AS GIVEN
	STRUCTURAL CHECKER:	CLIENT:	MINISTRY OF HIGHER EDUCATION
	DRAWN BY: HAWWA NISWA	SCALE: AS GIVEN	DIMENSION: MM
		DATE: SEPTEMBER 2021	PROJECT NO.: 21-001

A-15


CONCEPT AND DESIGN IN THIS DRAWING ARE THE PROPERTIES OF ARCHING STUDIO PVT LTD. UNAUTHORIZED USE OR REPRODUCTION OF PART OF THE DESIGN/DRAWINGS OR CONCEPT TO USE IN OTHER PROJECTS OR SITES OTHER THAN SPECIFIED ON THIS DRAWING IS PROHIBITED

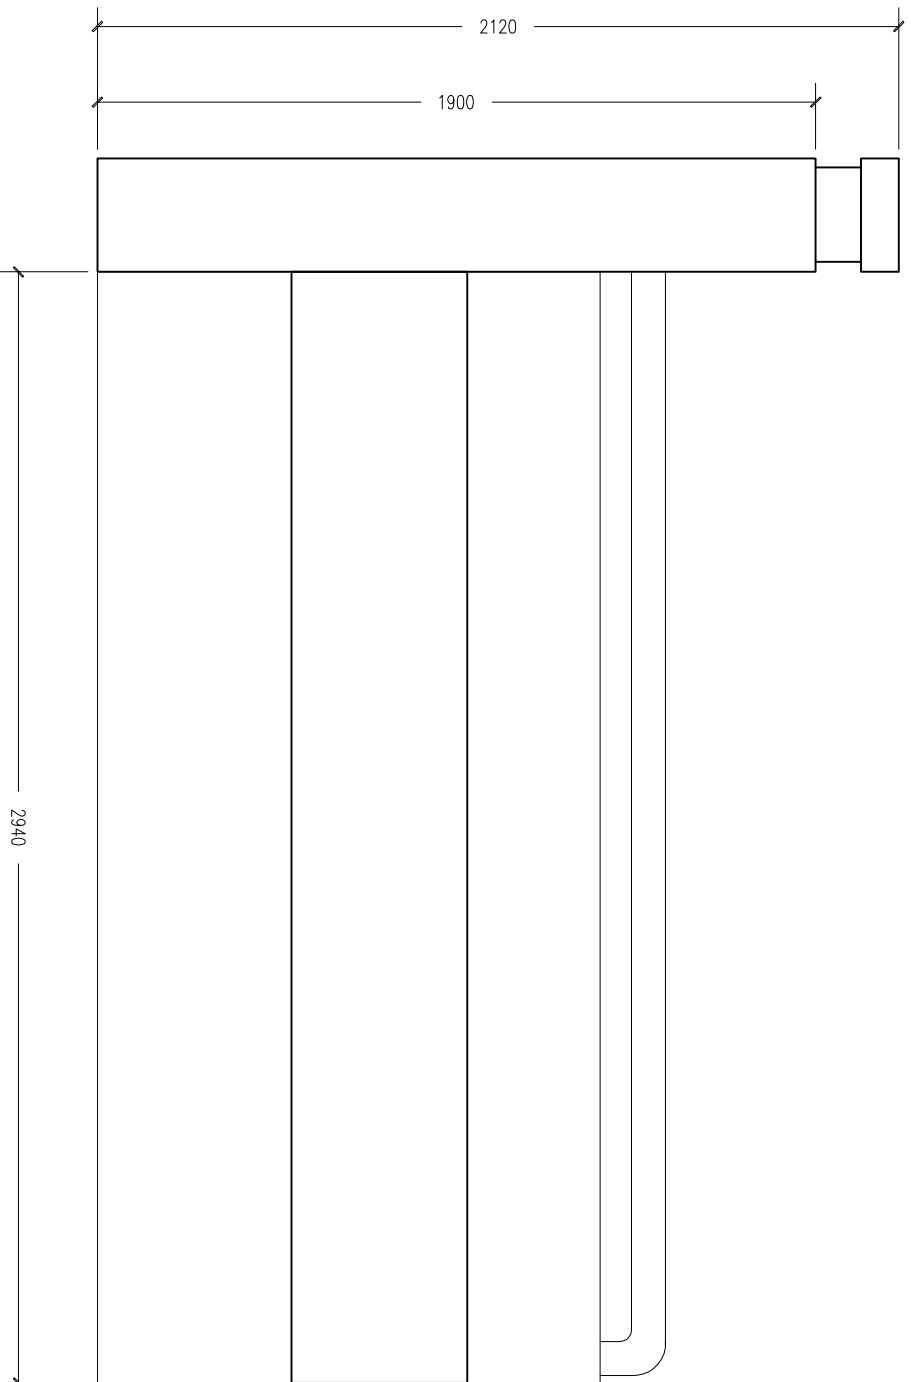

EXISTING BOUNDARY WALL
SCALE 1:20


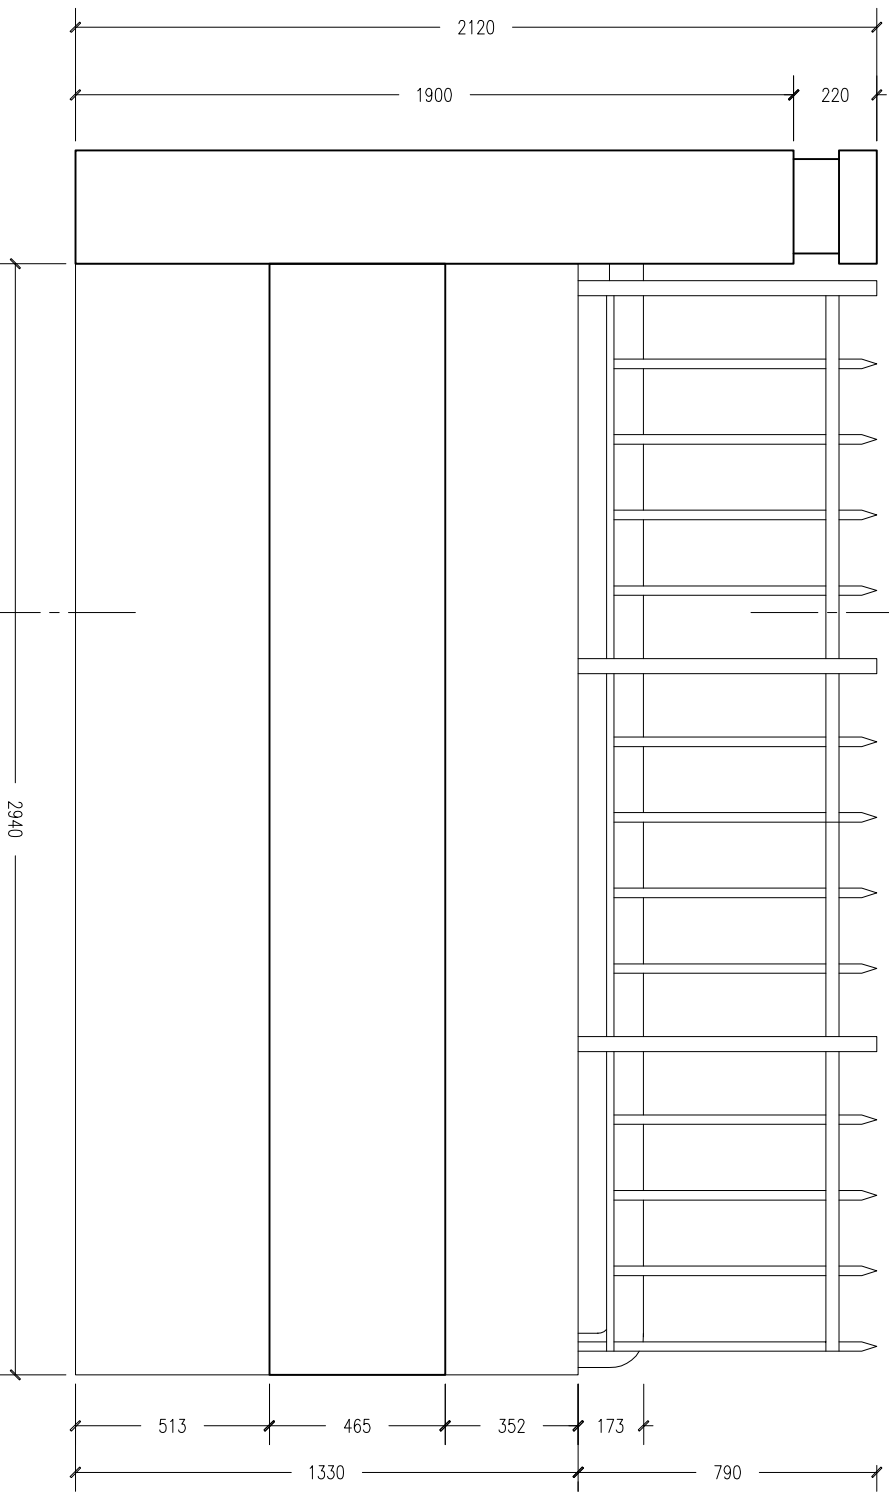


PROPOSED BOUNDARY WALL
SCALE 1:20

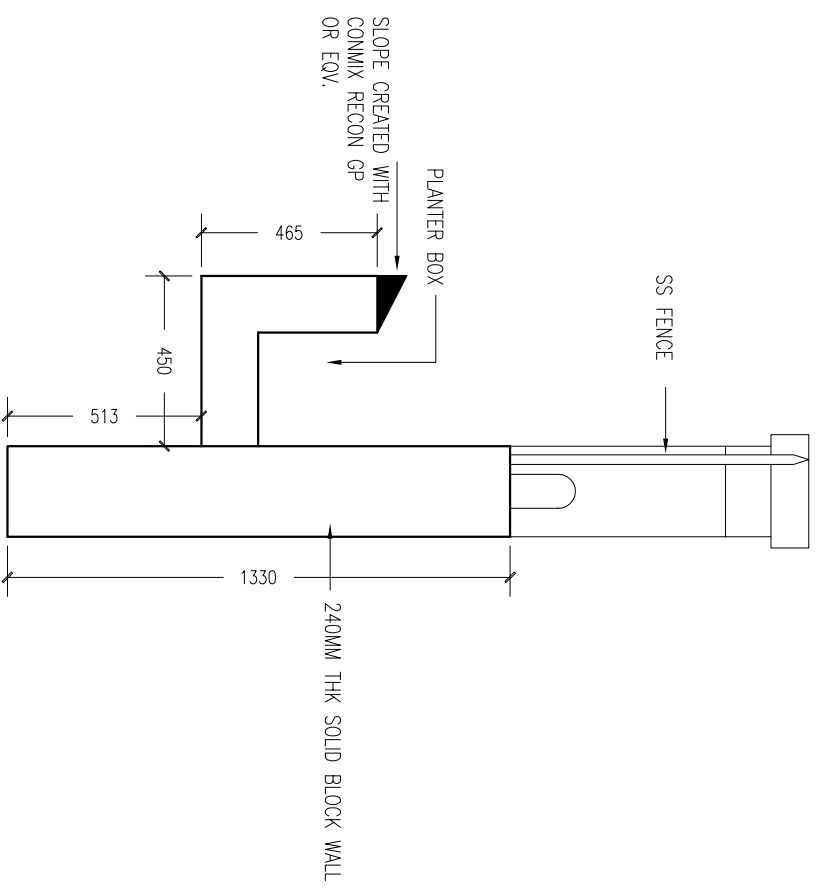




SECTION-Y
SCALE 1:20

CONTRACTORS MUST CHECK ALL DIMENSIONS ON SITE BEFORE STARTING ANY WORK OR SHOP DRAWINGS FIGURED DIMENSIONS TO TAKE PRECEDENCE OVER SCALE REMAINS

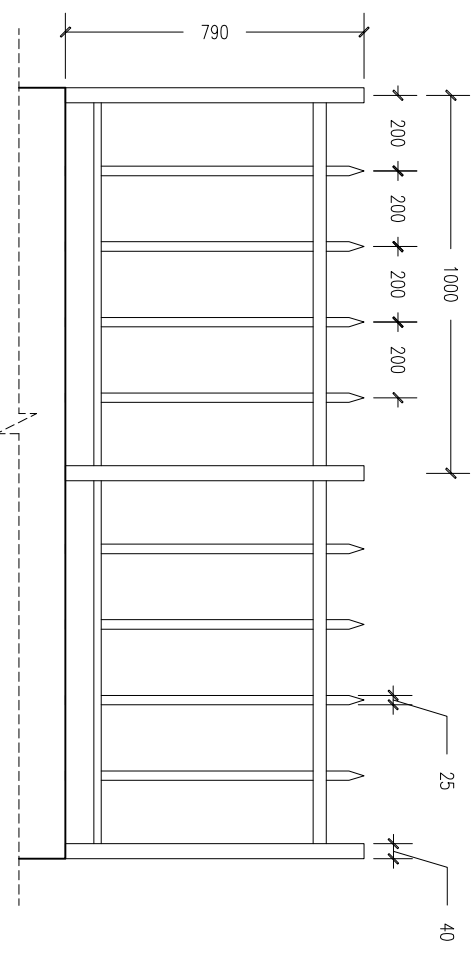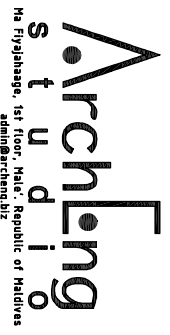


SS FENCE DETAIL
SCALE 1:20

REVISION:	ARCHITECT:	PROJECT:	MALDIVES POLYTECHNIC, KAMALE CAMPUS
	ENGINEER:	LOCATION:	KAMALE
	ARCHITECTURAL CHECKER:	DRAWING TITLE:	AS GIVEN
	STRUCTURAL CHECKER:	CLIENT:	MINISTRY OF HIGHER EDUCATION
	DRAWN BY:	SCALE:	AS GIVEN
		DIMENSION:	MM
		DATE:	SEPTEMBER 2021
CONCEPT AND DESIGN IN THIS DRAWING ARE THE PROPERTIES OF ARCHING STUDIO PVT.LTD. UNAUTHORIZED USE OR REPRODUCTION OF PART OF THE DESIGN/DRAWINGS OR CONCEPT TO USE IN OTHER PROJECTS OR SITES OTHER THAN SPECIFIED ON THIS DRAWING IS PROHIBITED			DWG NO
			PROJECT NO: 21-001
			A-16

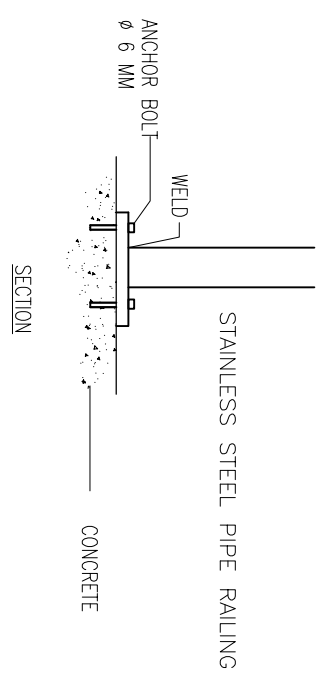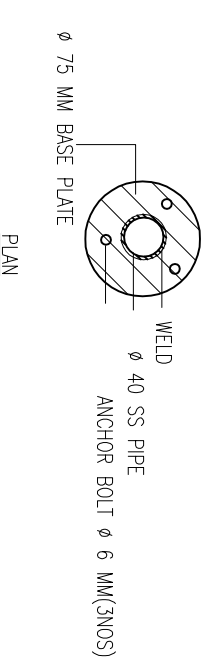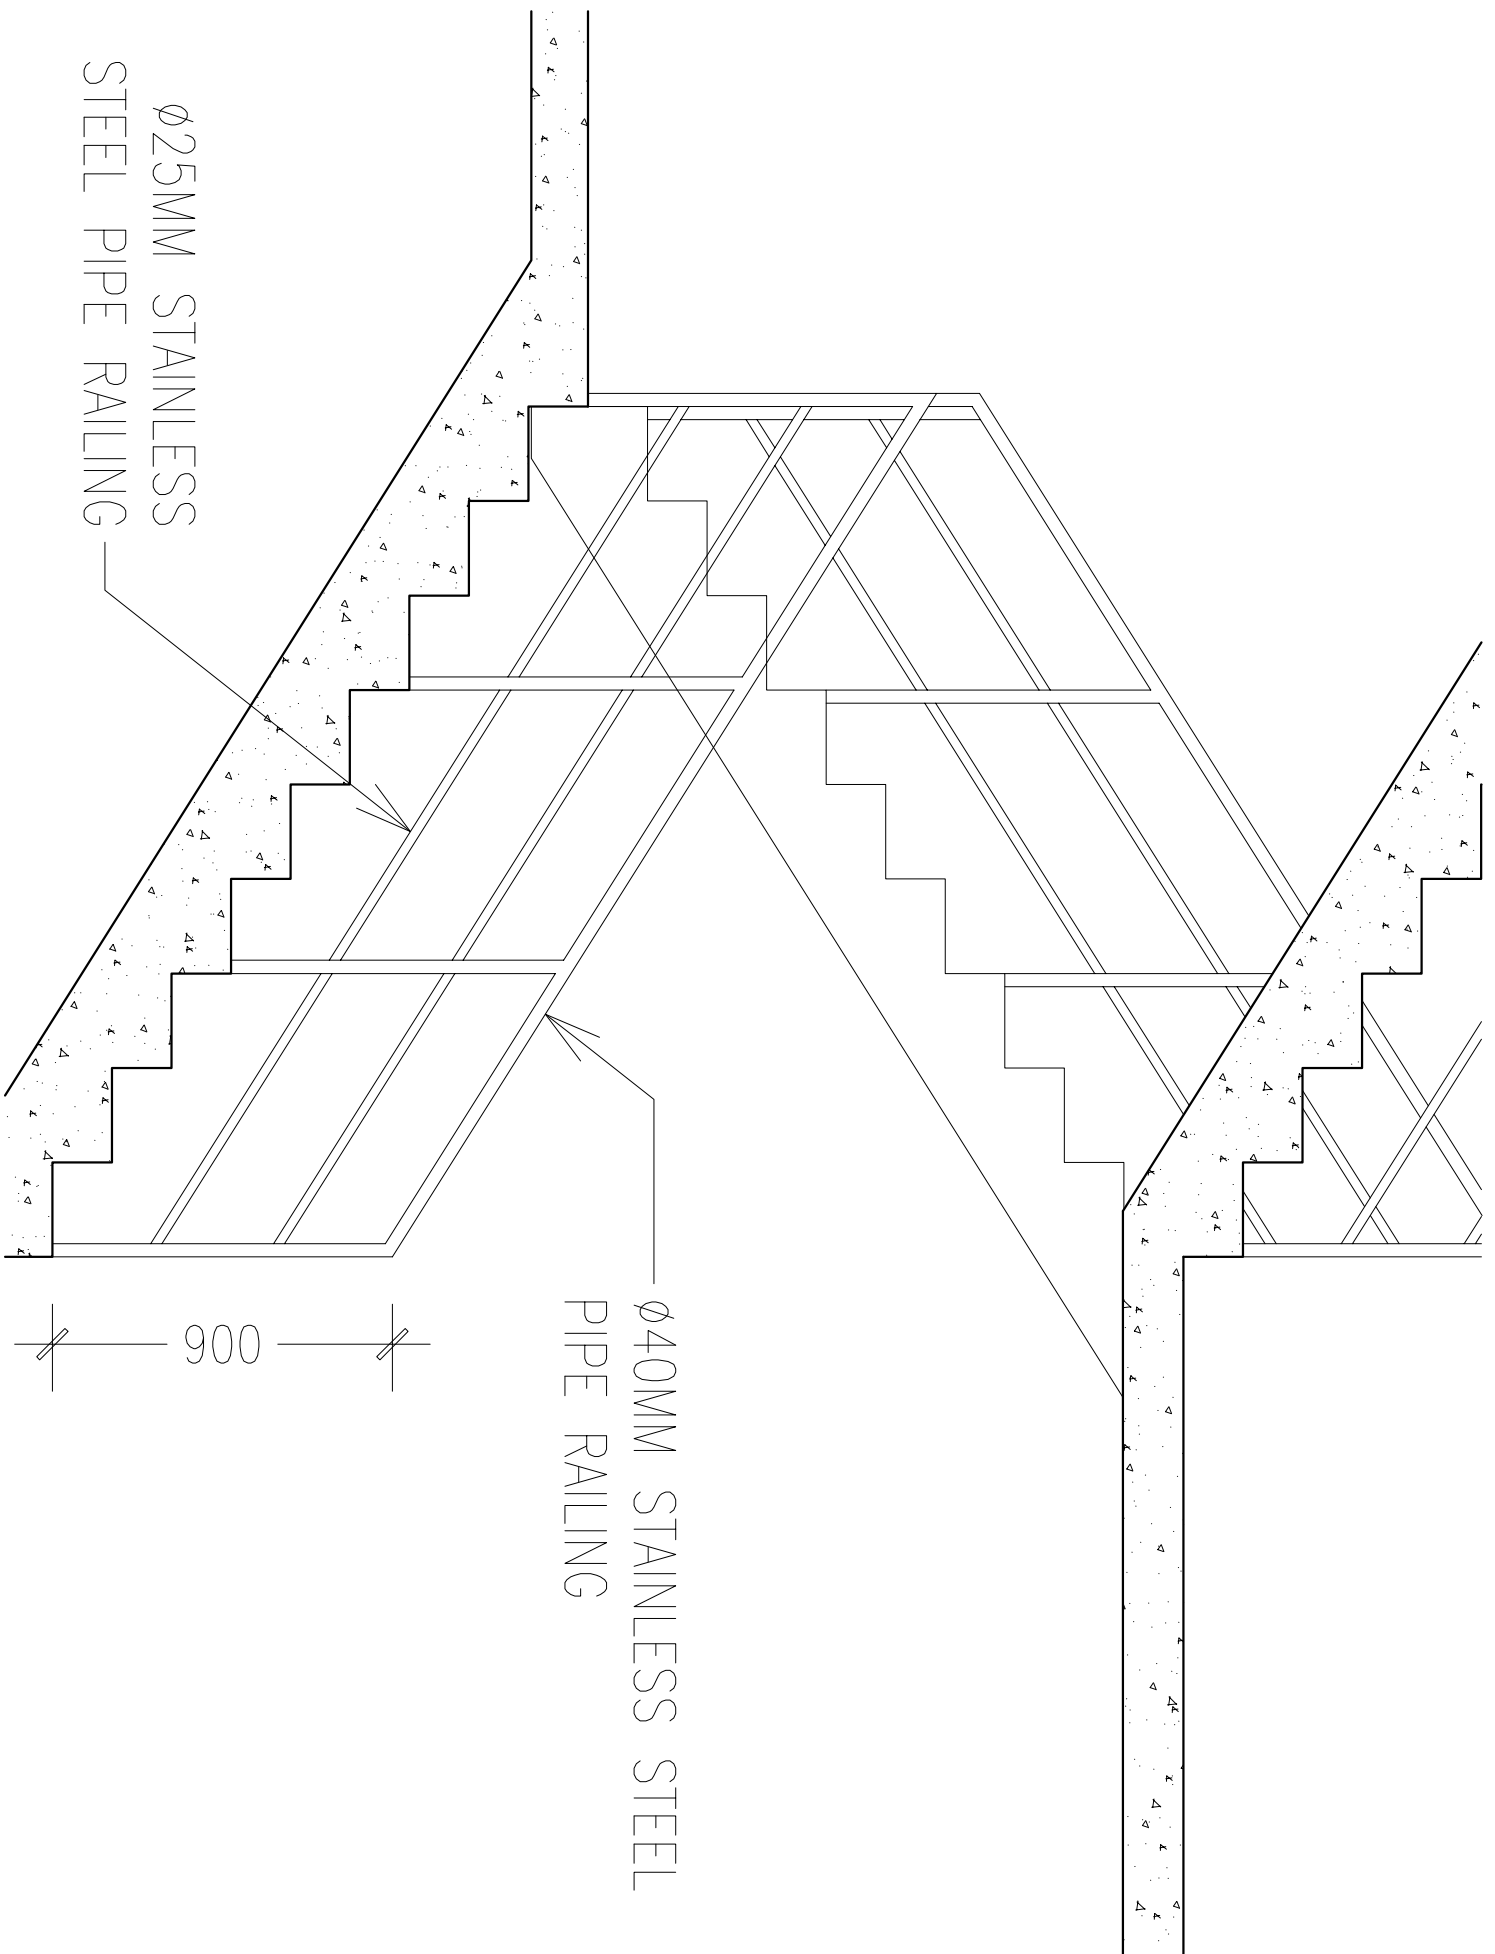


STUDENT STAIR CASE HAND RAIL DETAIL
SCALE 1:20

CONTRACTORS MUST CHECK ALL DIMENSIONS ON SITE BEFORE STARTING ANY WORK OR SHOP DRAWINGS FIGURED DIMENSIONS TO TAKE PRECEDENCE OVER SCALE REMAINS

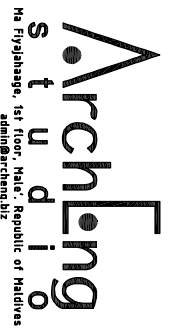


REVISION:	ARCHITECT:	PROJECT:	MALDIVES POLYTECHNIC, KJMALE CAMPUS	DWG NO	A-17
	ENGINEER: MARIYAM SAMAH	LOCATION: KJMALE		PROJECT NO: 24-001	
	ARCHITECTURAL CHECKER:	DRAWING TITLE: AS GIVEN			
	STRUCTURAL CHECKER:	CLIENT: MINISTRY OF HIGHER EDUCATION			
	DRAWN BY: HANMIVA NISIVA	SCALE: AS GIVEN	DIMENSION: MM	DATE: SEPTEMBER 2021	

CONCEPT AND DESIGN IN THIS DRAWING ARE THE PROPERTIES OF ARCHCHENG STUDIO PVT.LTD. UNAUTHORIZED USE OR REPRODUCTION OF PART OF THE DESIGN/DRAWINGS OR CONCEPT TO USE IN OTHER PROJECTS OR SITES OTHER THAN SPECIFIED ON THIS DRAWING IS PROHIBITED

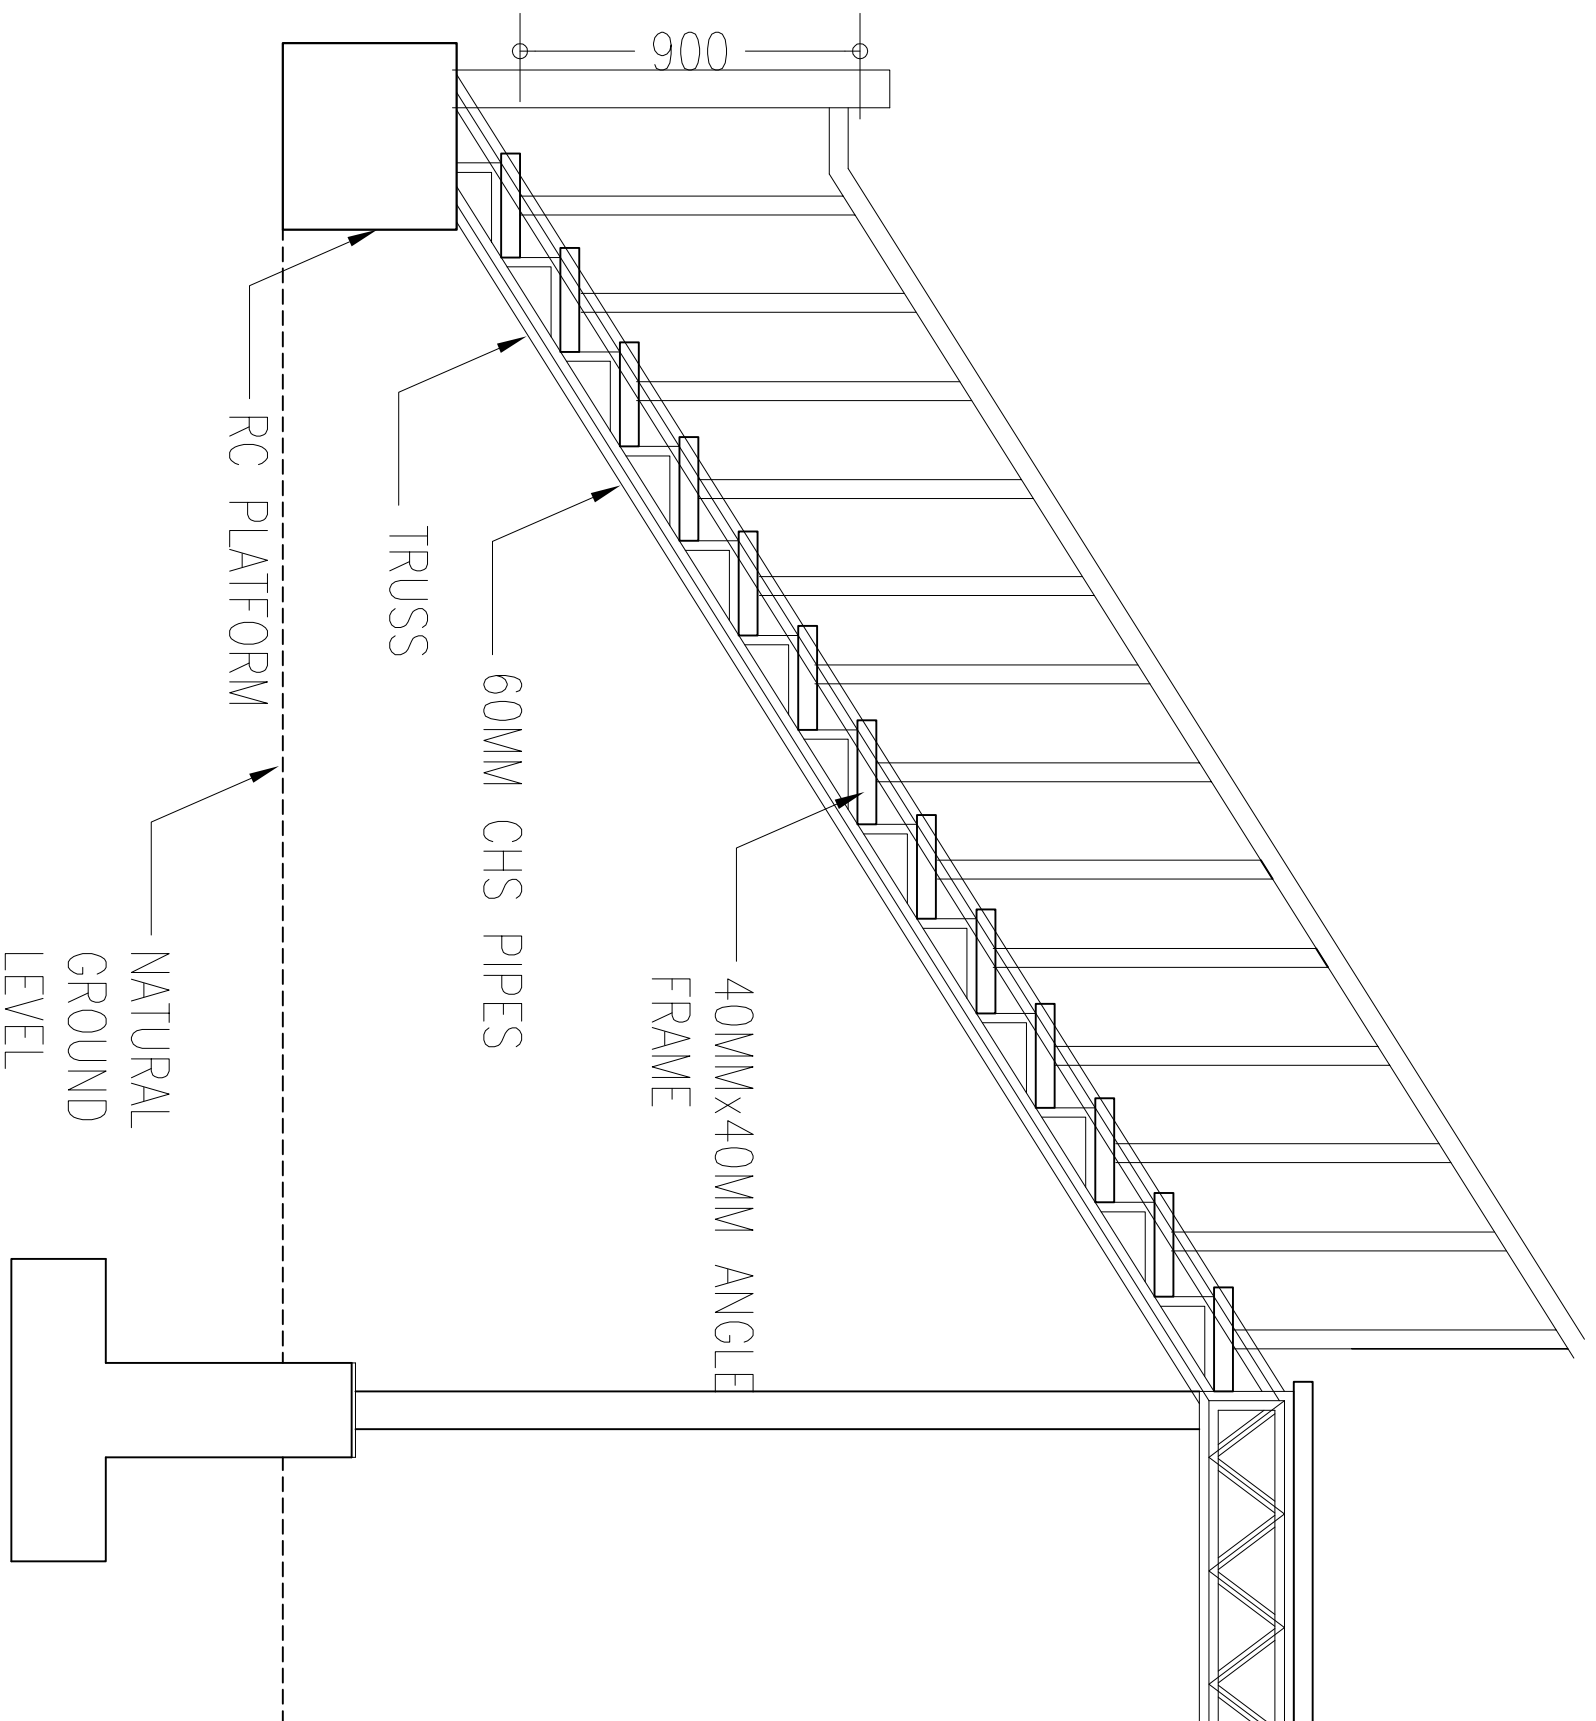

FIRE ESCAPE SECTION DETAIL
SCALE 1:20

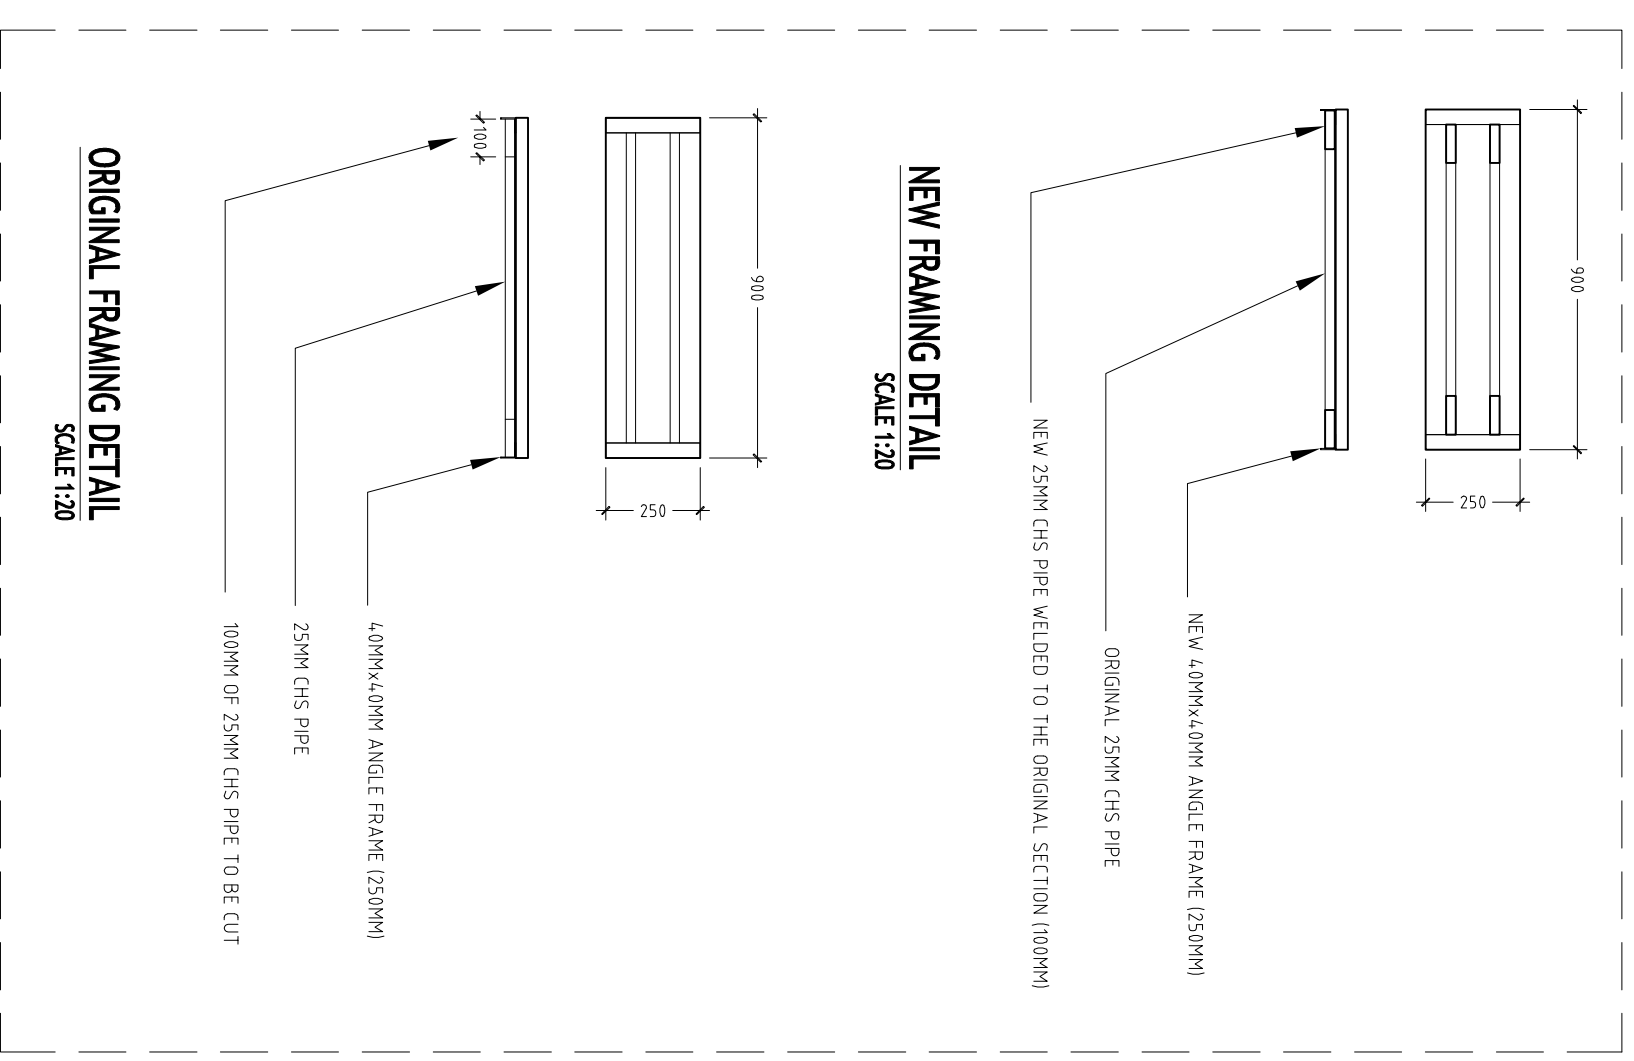



NEW FRAMING DETAIL
SCALE 1:20

ORIGINAL FRAMING DETAIL
SCALE 1:20


FIRE ESCAPE STAIRCASE STEPS REPAIR DETAIL
SCALE 1:20

CONTRACTORS MUST CHECK ALL DIMENSIONS ON SITE BEFORE STARTING ANY WORK OR SHOP DRAWINGS FIGURED DIMENSIONS TAKE PRECEDENCE OVER SCALE REMAINS

REVISION:	ARCHITECT:	PROJECT:	MALDIVES POLYTECHNIC, KAMALE CAMPUS
	ENGINEER:	LOCATION:	KAMALE
	ARCHITECTURAL CHECKER:	DRAWING TITLE:	AS GIVEN
	STRUCTURAL CHECKER:	CLIENT:	MINISTRY OF HIGHER EDUCATION
	DRAWN BY:	SCALE:	AS GIVEN
		DIMENSION:	MM
		DATE:	SEPTEMBER 2021
		PROJECT NO.:	21-001

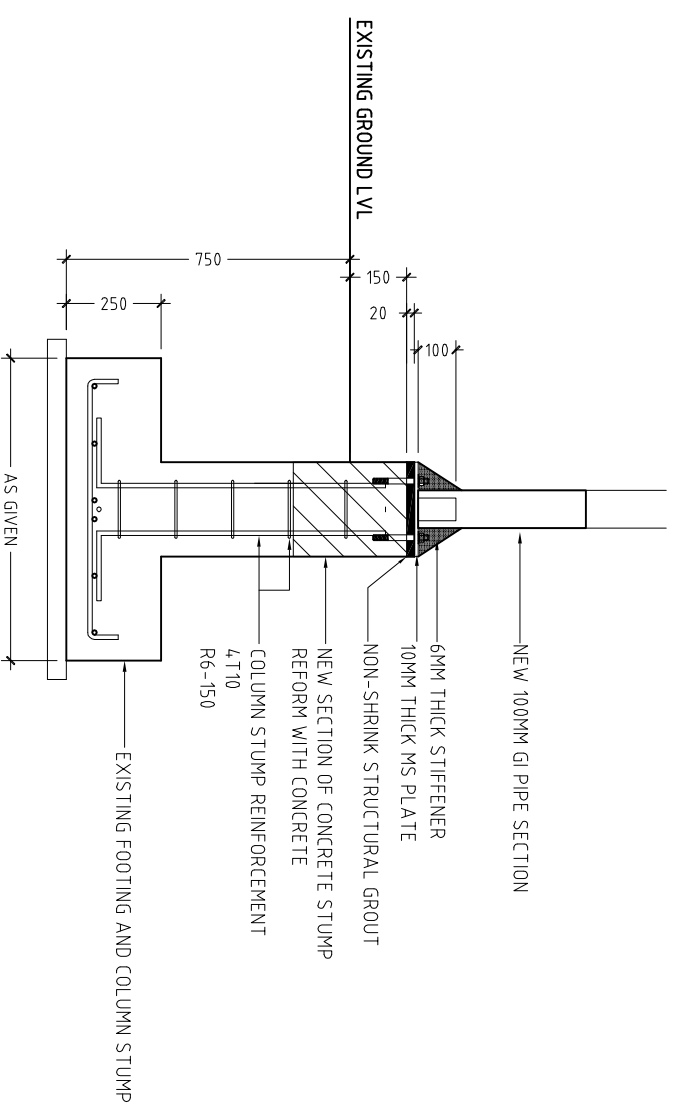
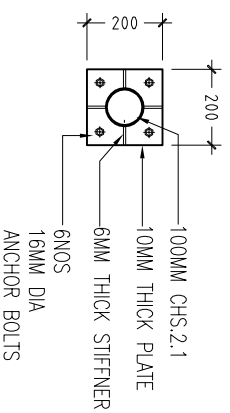


NEW COLUMN BASE DETAIL

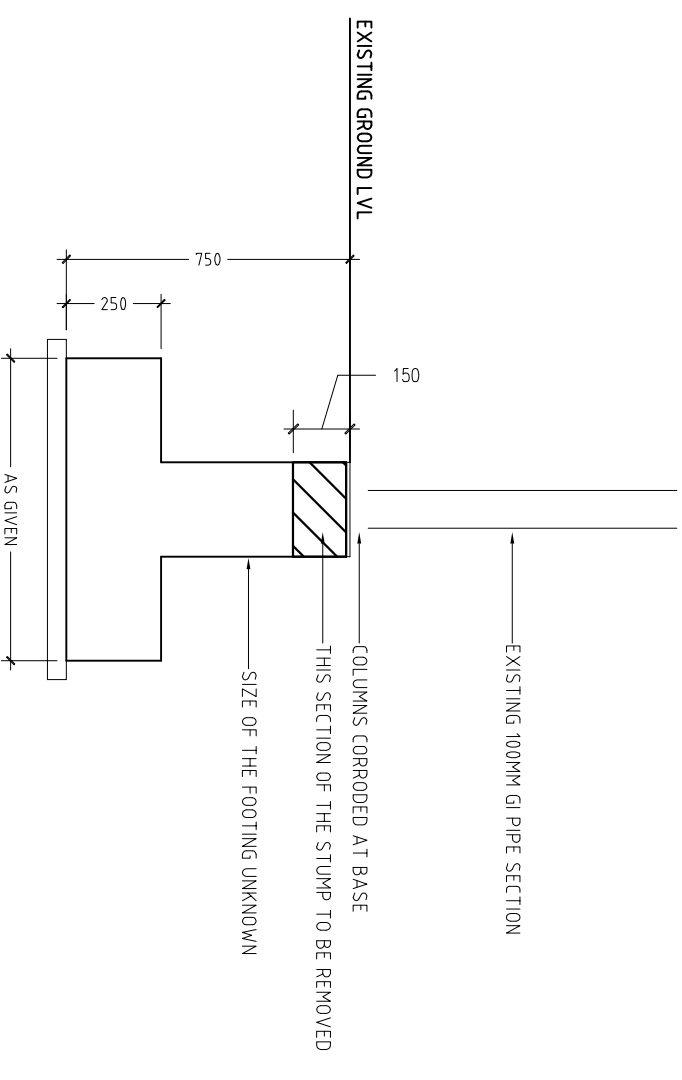


EXISTING COLUMN DETAIL

FIRE ESCAPE BASE REPAIR DETAILS
SCALE 1:20

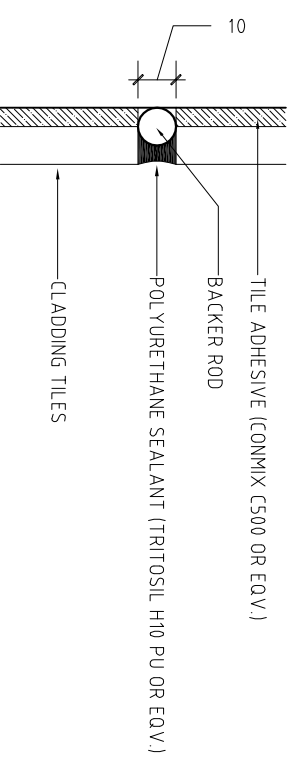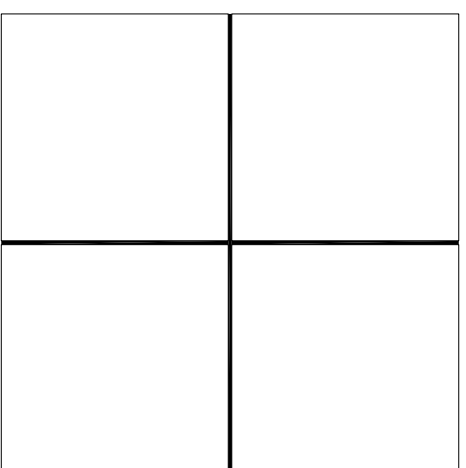

EXTERIOR WALL CLADDING DETAIL
SCALE 1:20

CONTRACTORS MUST CHECK ALL DIMENSIONS ON SITE BEFORE STARTING ANY WORK OR SHOP DRAWINGS FIGURED DIMENSIONS TO TAKE PRECEDENCE OVER SCALE REMAINS

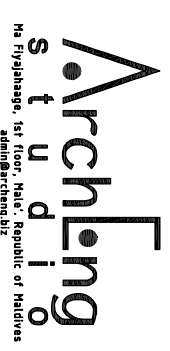

REVISION:	ARCHITECT:	PROJECT:	MALDIVES POLYTECHNIC, KAMALE CAMPUS
	ENGINEER: MARIYAM SAMAH	LOCATION:	KAMALE
	ARCHITECTURAL CHECKER:	DRAWING TITLE:	AS GIVEN
	STRUCTURAL CHECKER:	CLIENT:	MINISTRY OF HIGHER EDUCATION
	DRAWN BY: HANMVA NISIVA	SCALE: AS GIVEN	DIMENSION: MM
		DATE: SEPTEMBER 2021	
CONCEPT AND DESIGN IN THIS DRAWING ARE THE PROPERTIES OF ARCHENG STUDIO PVT.LTD. UNAUTHORIZED USE OR REPRODUCTION OF PART OF THE DESIGN/DRAWINGS OR CONCEPT TO USE IN OTHER PROJECTS OR SITES OTHER THAN SPECIFIED ON THIS DRAWING IS PROHIBITED			DWG NO
			PROJECT NO: 21-001
			A-19