


HULHUMALE MAP

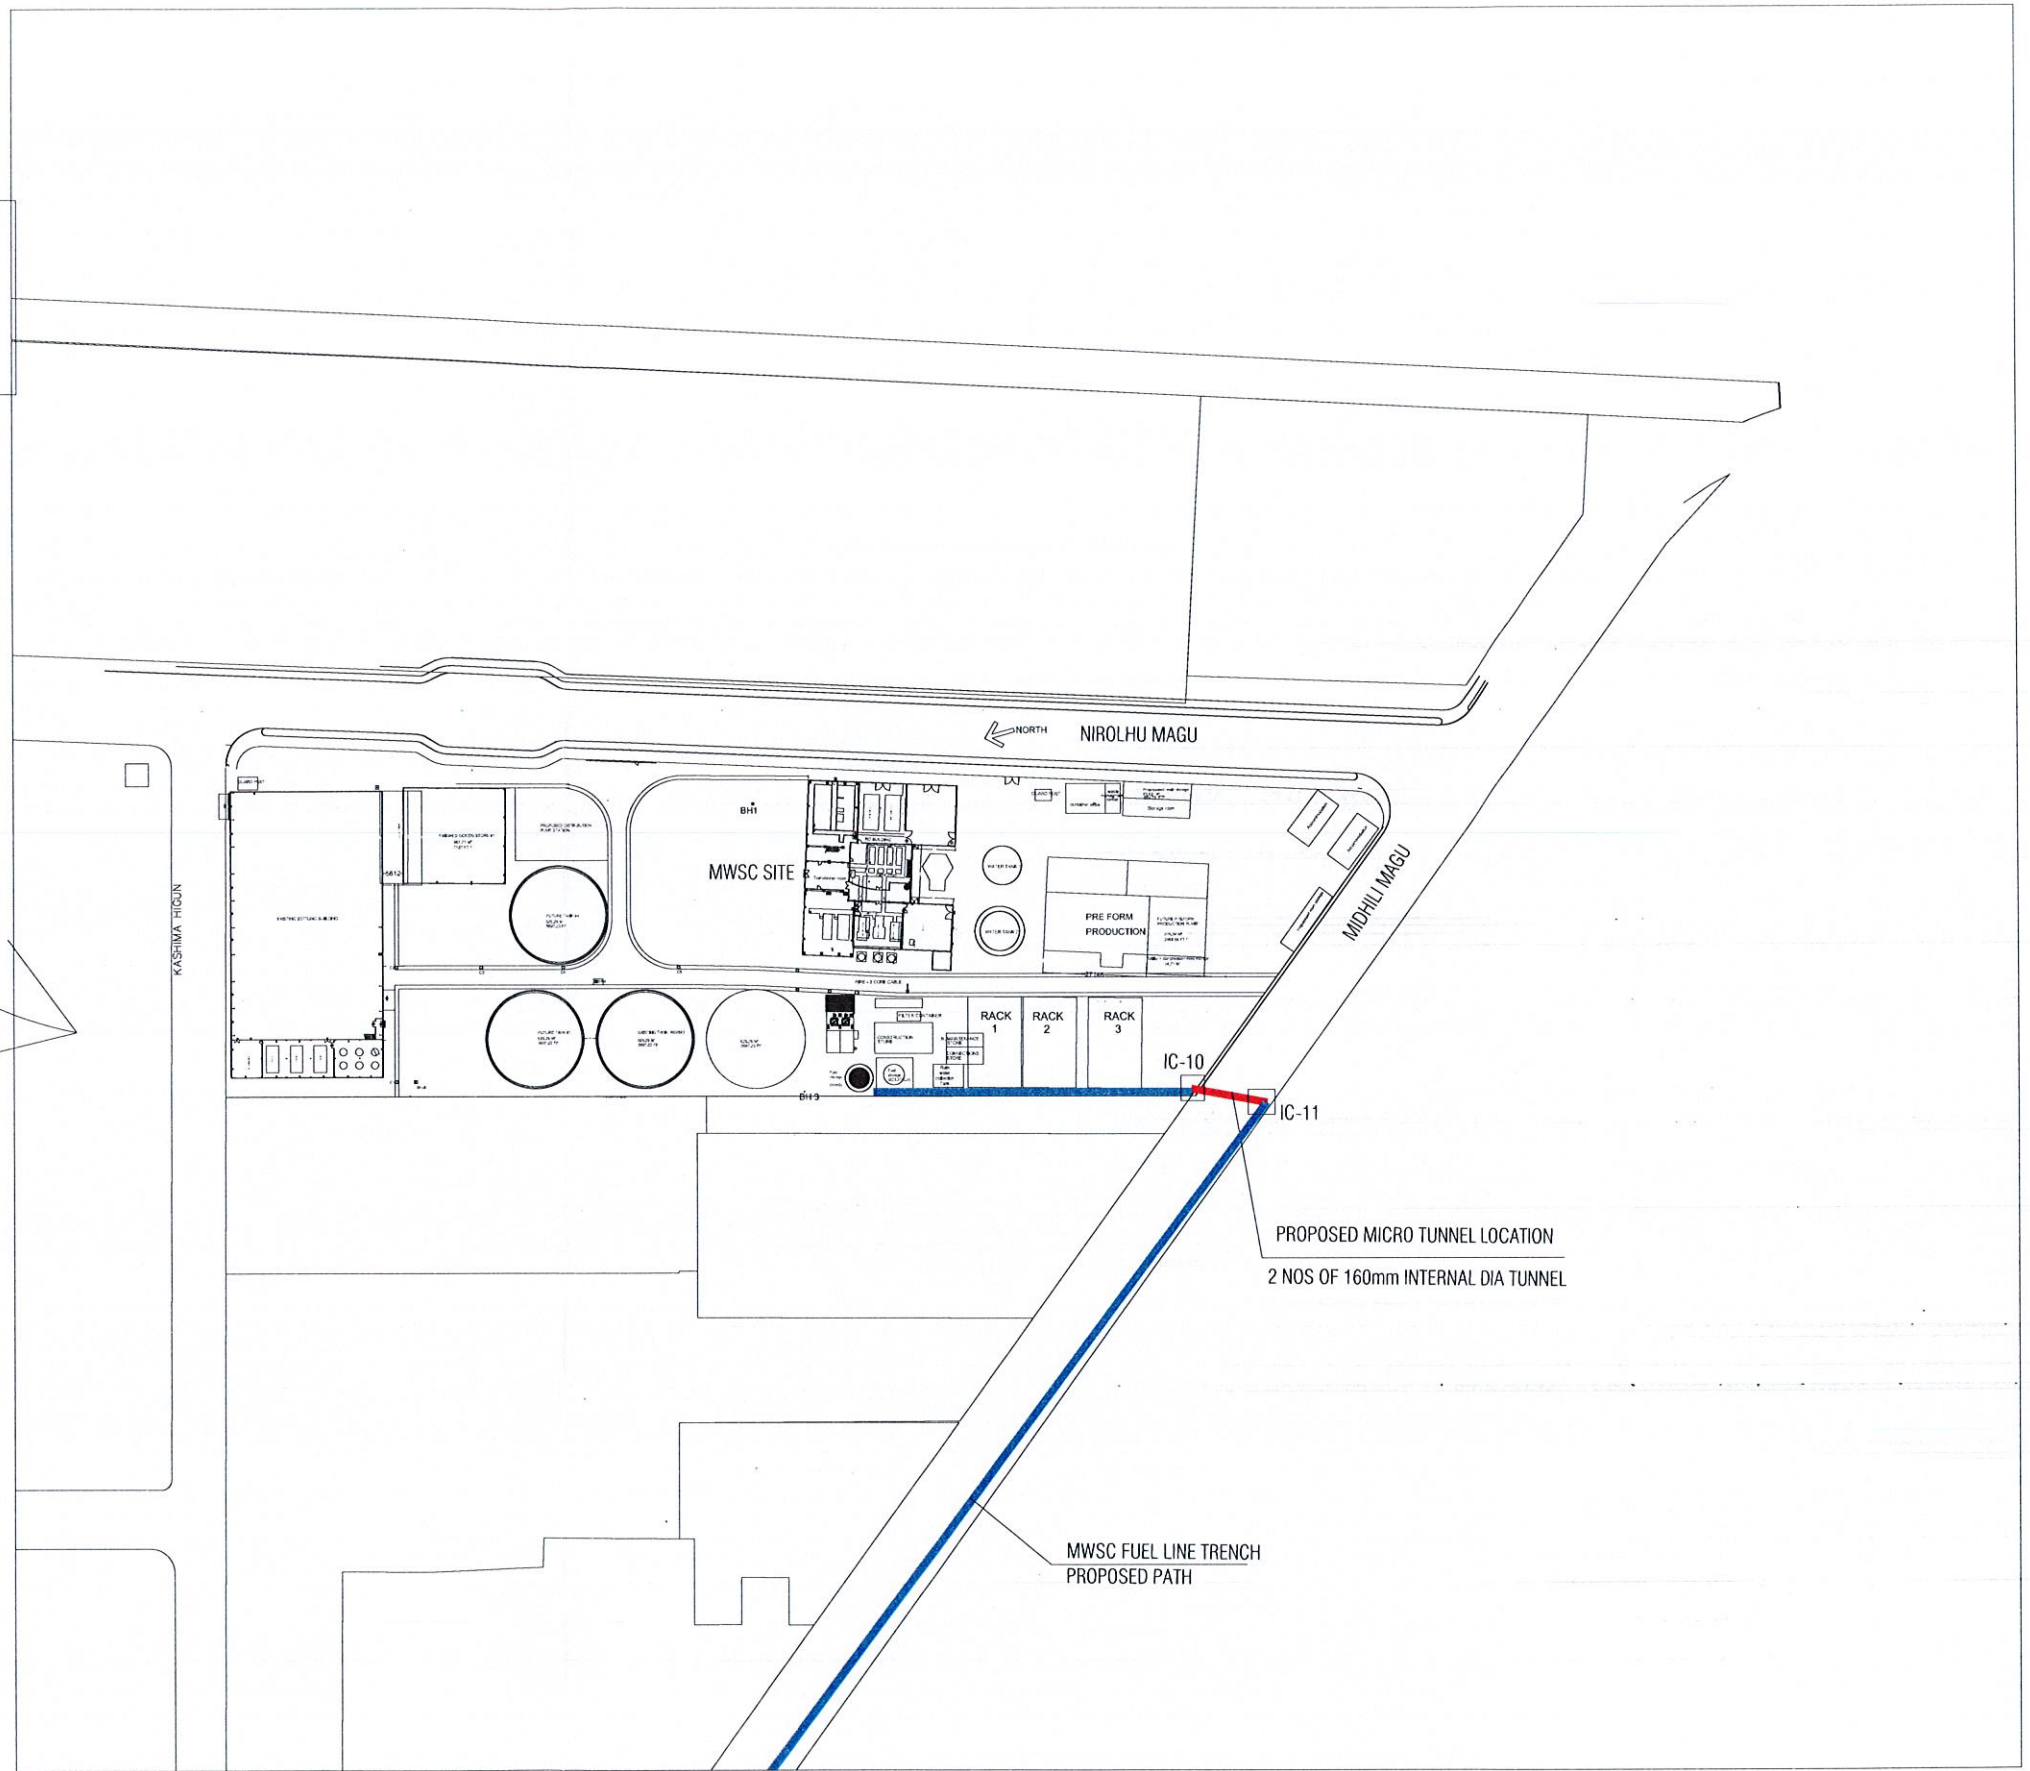

LEGEND

- PROPOSED FUEL LINE TRENCH PATH
- PROPOSED FUEL LINE TUNNEL PATH

APPROVED BY


*(Signature)*

*(Signature)*

PROJECT	DESIGN AND CONSTRUCTION OF 2 NOS OF MICRO TUNNEL AT HULHUMALE PHASE 1
TITLE	SITE PLAN
CLIENT DEPARTMENT	OPERATIONS DEPARTMENT
DESIGN CONTRACTOR	PLANNING AND DESIGN DEPARTMENT
PAPER SIZE	A3
PAGE NO.	02

DESIGN BY	MOHAMED NAHAAS
STRUCTURE BY	AISHATH NADHA GASIM
DRAWN BY	MOHAMED NAHAAS
SCALE	AS SHOWN
DWG NO.	21-I35-HM-FL-A0-01
DATE	17.10.2020

AMENDMENTS

**MALDI WATER & SEWERAGE COMPANY PVT. LTD.**  
 ދިވެހިސަރުކާރުގެ ގެޒެޓް ގައި ބަޔާންކޮށްފައިވާ ޖަހާފައިވާ ޕްރައިވެޓް ކޮމްޕަނީ ލިމިޓެޑް  
 ދިވެހިސަރުކާރުގެ ގެޒެޓް ގައި ބަޔާންކޮށްފައިވާ ޖަހާފައިވާ ޕްރައިވެޓް ކޮމްޕަނީ ލިމިޓެޑް  
 TEL: (+960) 3322299 FAX: (+960) 3322438 E-MAIL: mwsc@mwsc.mv

MWSC-CL1-F-04