


**SECRETARIAT OF THE H. A.  
DHIDHDHOO COUNCIL**

**PROPOSED SINGLE STOREY OFFICE  
EXTENSION BUILDING**

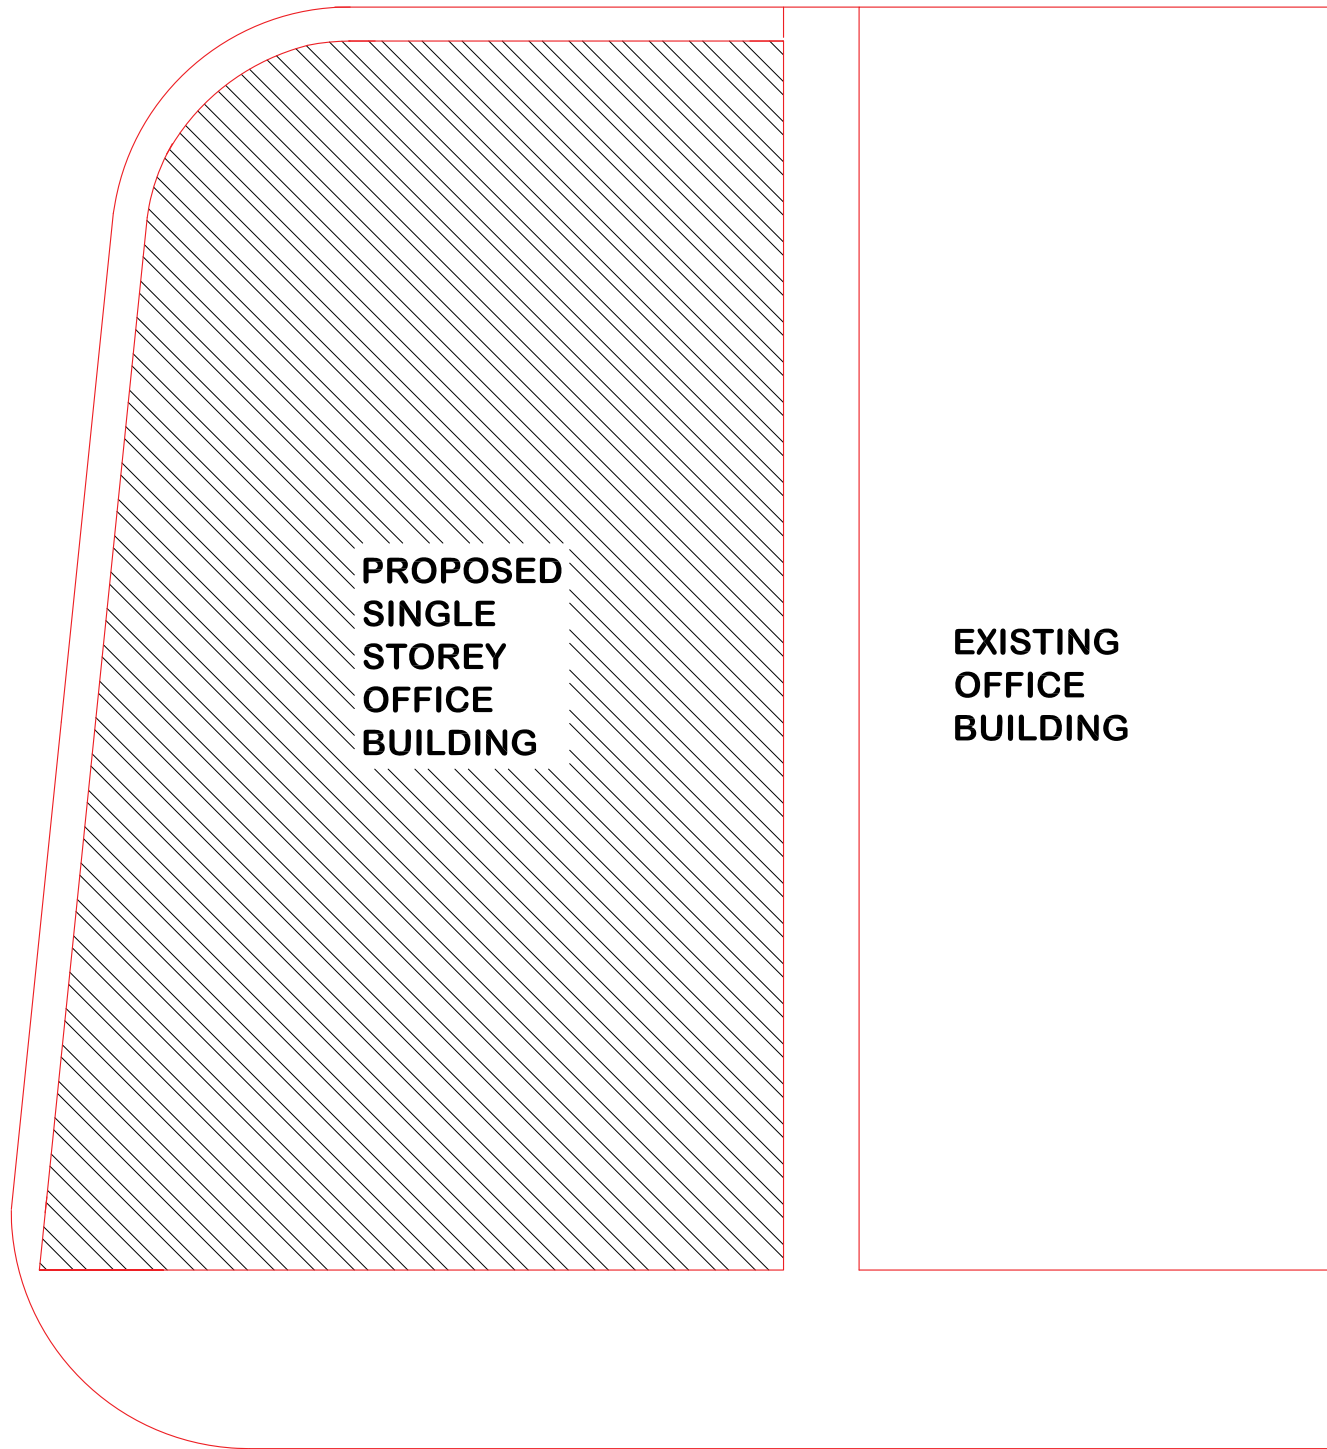

SITE LAYOUT  
SCALE 1:100

REMARKS:

CLIENT:

SECRETARY OF

DHIDHDHD COUNCIL

PROJECT:

GRAND OFFICE

EXTENSION

HA DHIDHDHD

DESIGNERS:

RASHEED

ARCHITECTURAL CHECKER

STRUCTURAL ENGINEER & CHECKER

SCALE : AS GIVEN


DWG TITLE : AS GIVN

DWG NO. : 0



D H I V E S H I  
CONSTRUCTION &  
CONSULTANCY

Project Management,  
Building Cost Estimating,  
Building Services  
Consultancy

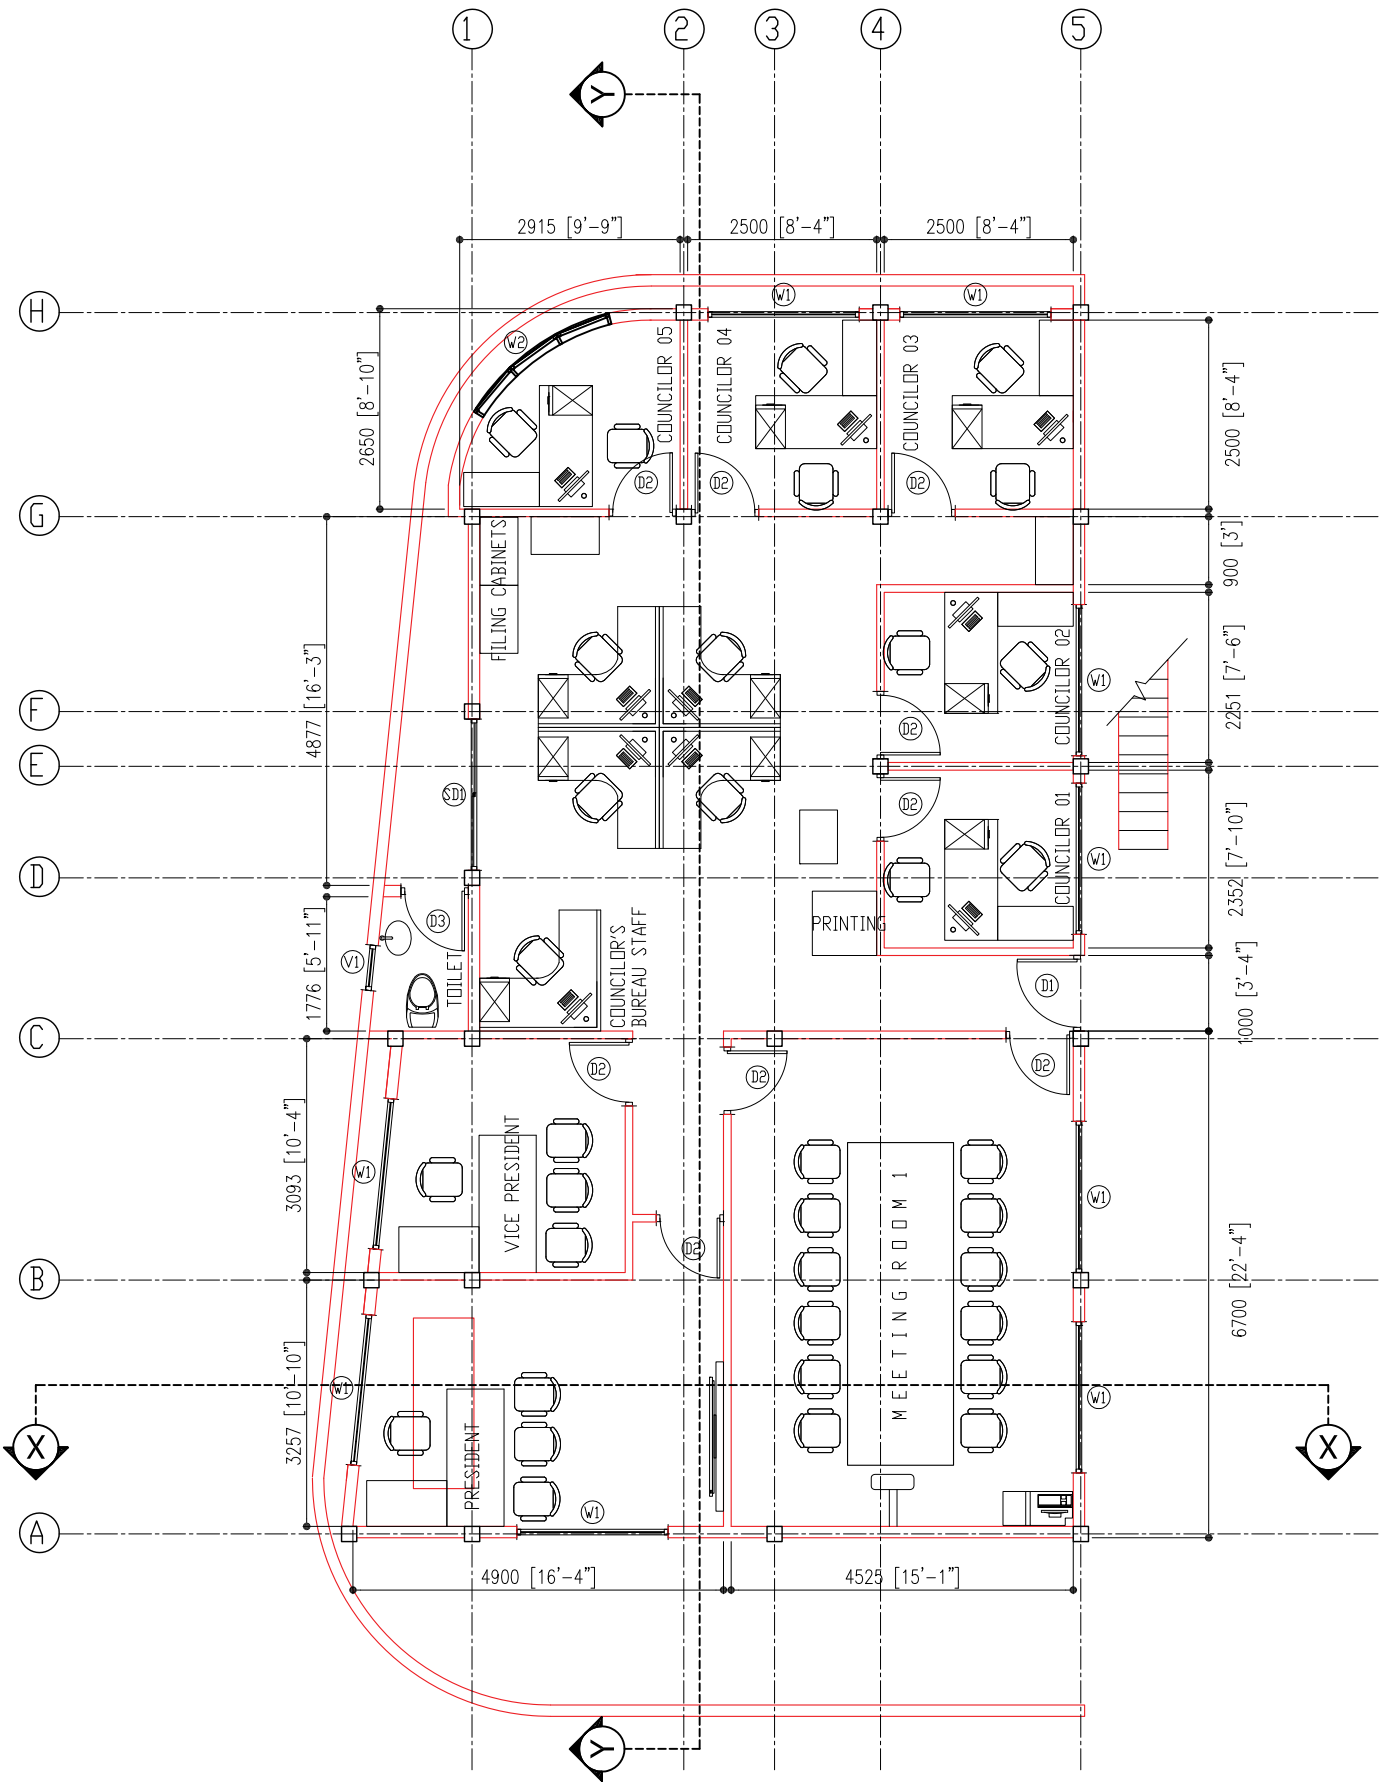

# GROUND FLOOR PLAN

SCALE 1:100

REMARKS:

CLIENT:

SECRETARY OF

DHHDHDD COUNCIL

PROJECT:

COUNCIL OFFICE

EXTENSION

HA DHHDHDD

DESIGNERS:

MARKED

ARCHITECTURAL CHECKER

STRUCTURAL ENGINEER & CHECKER


SCALE : AS GIVEN

DWG TITLE : AS GIVEN

DWG NO. : 10

**D H I V E S H I**  
CONSULTANCY

Project Management,  
Building Cost Estimating,  
Construction &  
Consultancy

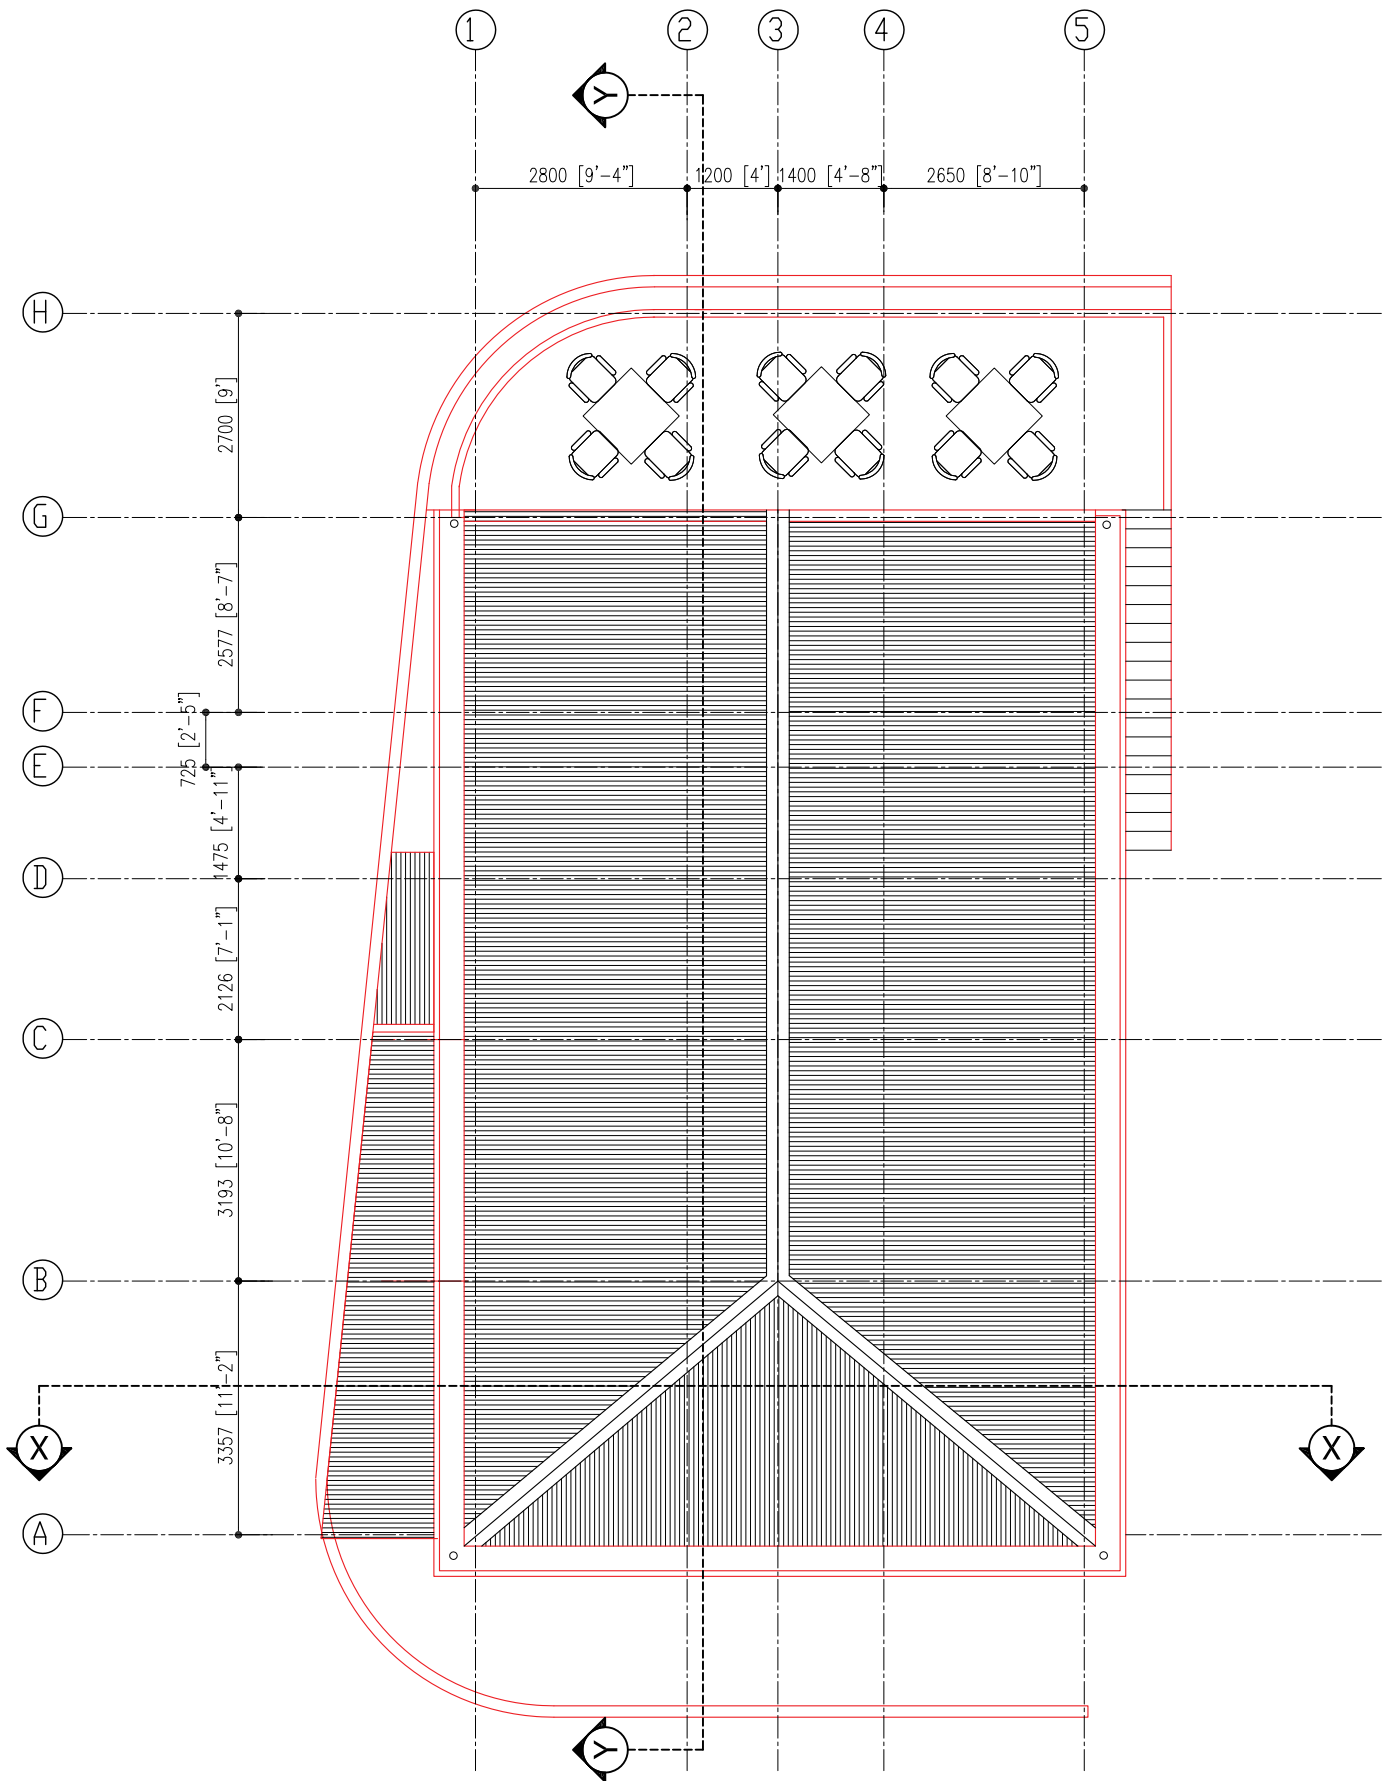

# ROOF & TERRACE PLAN

SCALE 1:100

REMARKS:

CLIENT:

SECRETARY OF

DHHDHDD COUNCIL

PROJECT:

COUNCIL OFFICE

EXTENSION

HA DHHDHDD

DESIGNERS:

MAKED

ARCHITECTURAL CHECKER


STRUCTURAL ENGINEER & CHECKER

SCALE : AS GIVEN


DWG TITLE : AS GIVEN

DWG NO. : 02



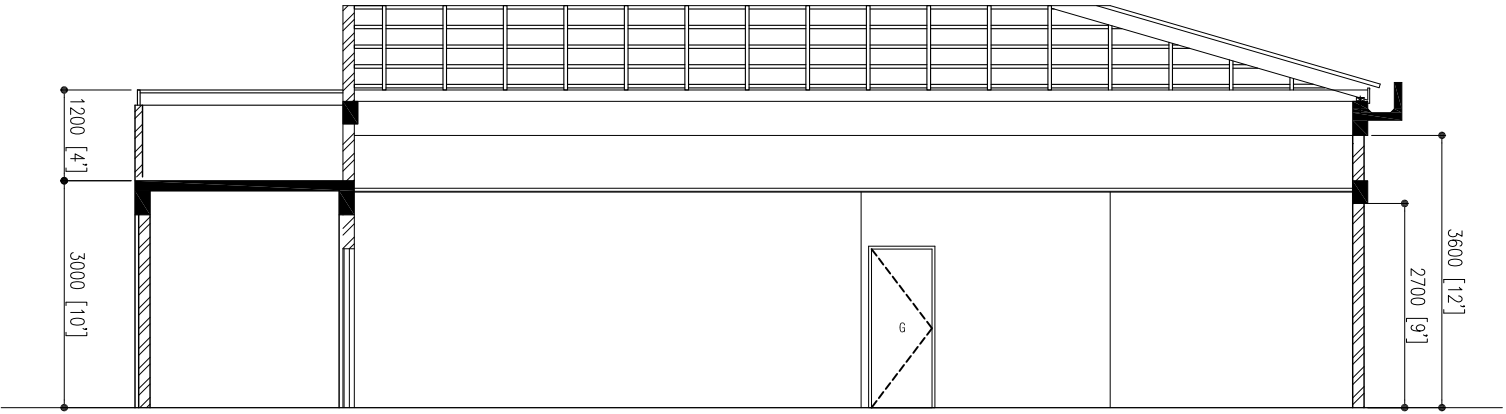

ELEVATION - Y  
SCALE 1:50

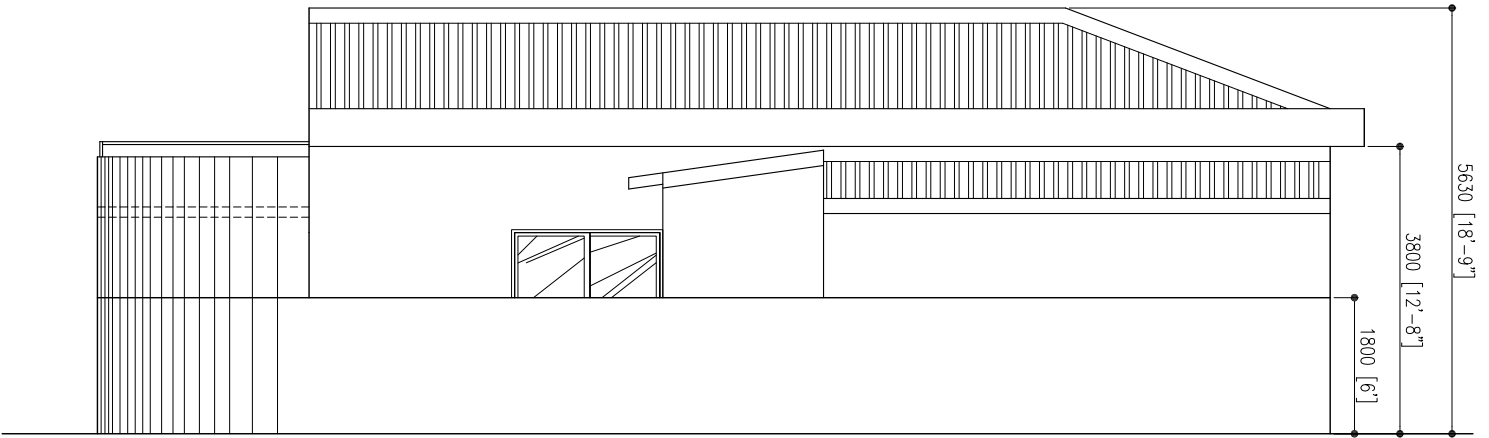

ELEVATION - A  
SCALE 1:50

REMARKS:

CLIENT:

SECRETARY OF

DHHDHDD COUNCIL

PROJECT:

COUNCIL OFFICE

EXTENSION

H.A. DHHDHDD

DESIGNERS:

MAKED


ARCHITECTURAL CHECKER

STRUCTURAL ENGINEER & CHECKER

SCALE : AS GIVEN

DWG TITLE : AS GIVEN

DWG NO. : 03

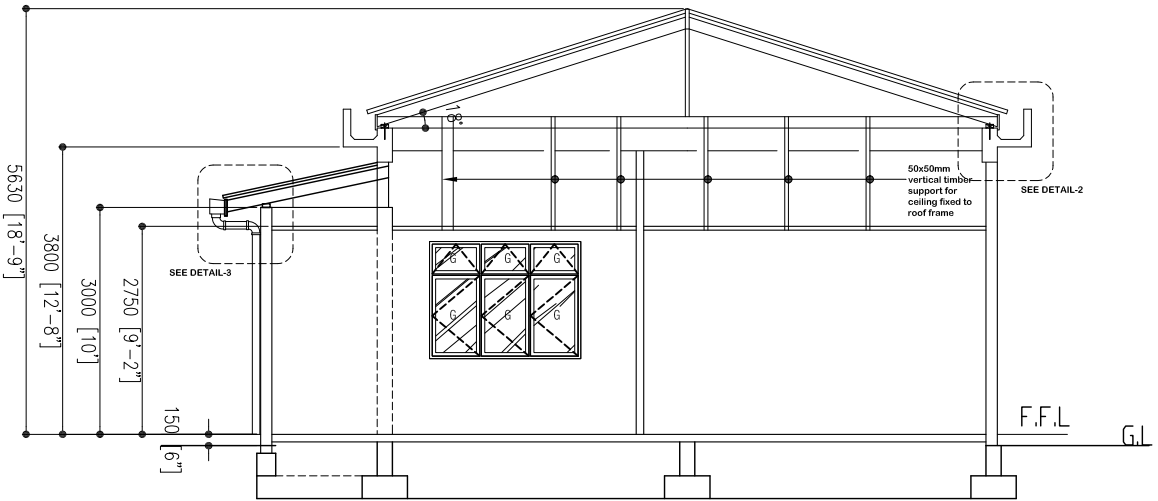

ELEVATION - X  
SCALE 1:50

REMARKS:

CLIENT:

SECRETARY OF

DHIDHDHDD COUNCIL

PROJECT:

COUNCIL OFFICE

EXTENSION

H.A. DHIDHDHDD

DESIGNERS:

DRAWN


ARCHITECTURAL CHECKER

STRUCTURAL ENGINEER & CHECKER

SCALE : AS GIVEN

DWG TITLE : AS GIVEN

DWG NO. : 04

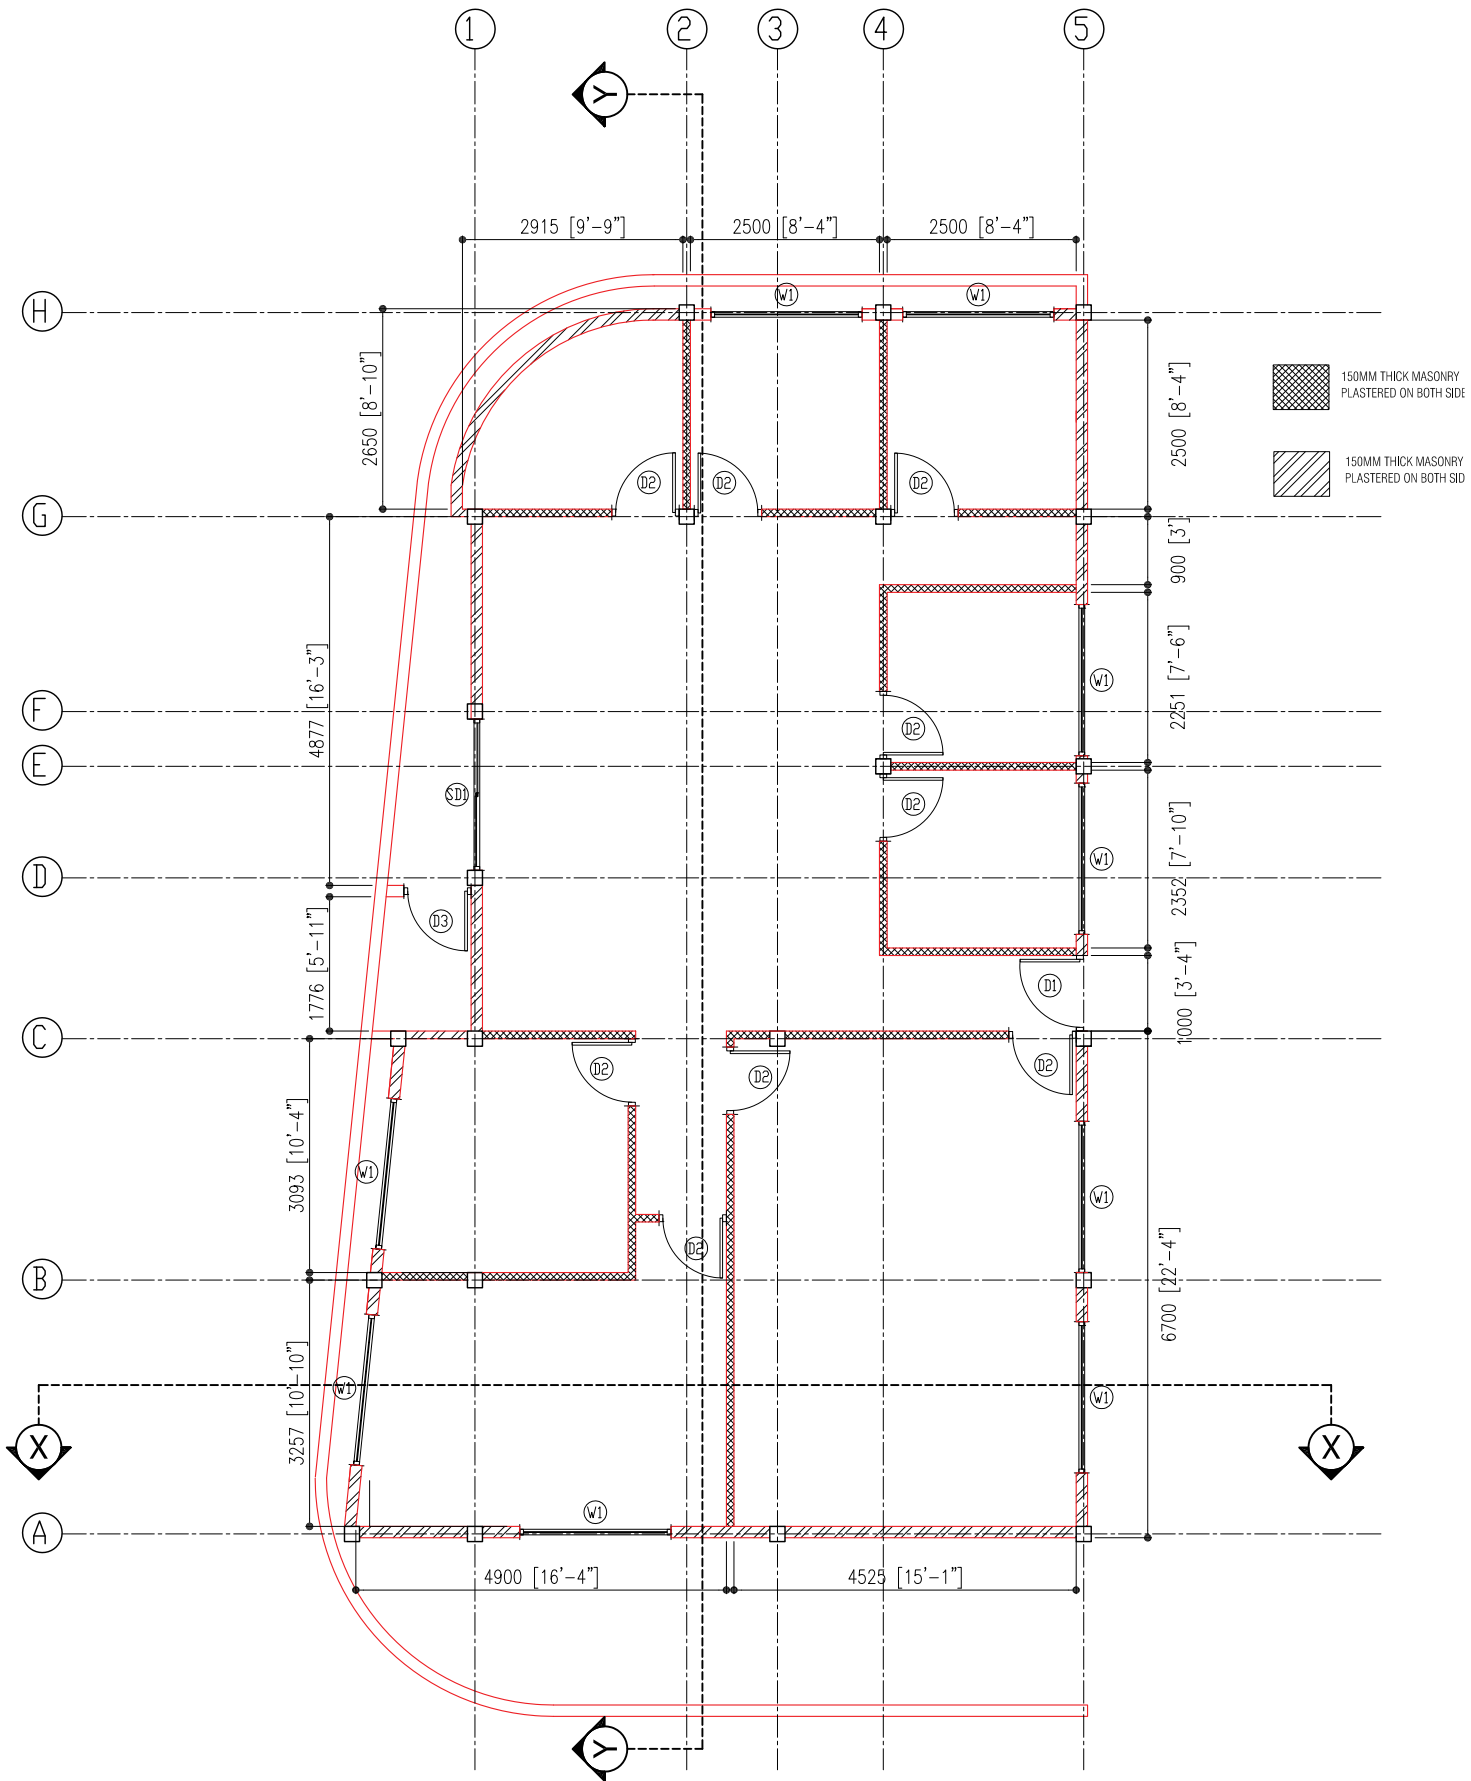

WALL LAYOUT  
SCALE 1:100

REMARKS:

CLIENT:

SECRETARY OF

DHHDHDD COUNCIL

PROJECT:

COUNCIL OFFICE

EXTENSION

HA DHHDHDD

DESIGNERS:

MAHED

ARCHITECTURAL CHECKER

STRUCTURAL ENGINEER & CHECKER

SCALE : AS GIVEN


DWG TITLE : AS GIVEN

DWG NO : 05



D H I V E S H I  
CONSTRUCTION &  
CONSULTANCY

Project Management,  
Building Cost Estimating,  
Construction &  
Consultancy

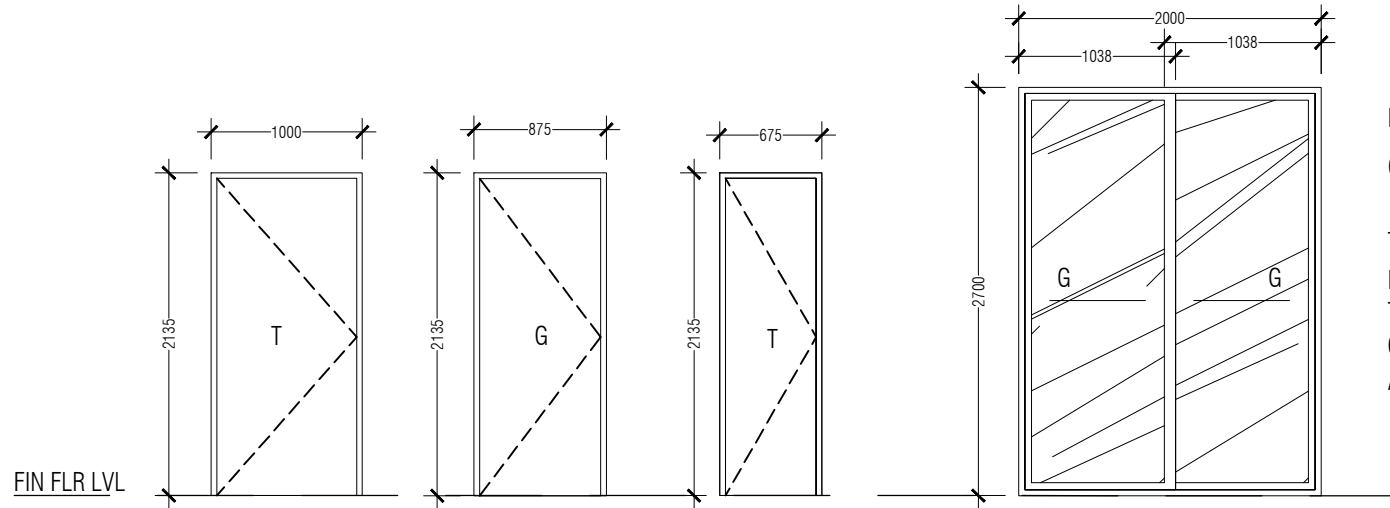

- KEY
- G - GLASS
  - TG - TEMPERED GLASS
  - FAL - FIXED ALUMINIUM LOUVERS
  - T - TIMBER
  - GL - GLASS LOUVERS
  - A - ALUMINIUM

TYPE	DOOR D1	DOOR D2	DOOR D3	SLIDING DOOR SD1
FRAME	TIMBER	ALUMINIUM	TIMBER	ALUMINIUM
FINISHING		POWDER COAT		POWDER COAT
GLAZING		6MM THICK CLEAR GLASS		6MM THICK CLEAR GLASS
OPEN AREA				1.26 SQ.M

**DOORS & WINDOWS SCHEDULE 1**  
**SCALE - 1:50**

REMARKS:

CLIENT:

SECRETARY OF  
 DHIDHDHDD COUNCIL

PROJECT:

COUNCIL OFFICE  
 EXTENSION  
 H.A DHIDHDHDD

DESIGNERS:

RASHEED  
 ARCHITECTURAL CHECKER:

STRUCTURAL ENGINEER & CHECKER:

SCALE : AS GIVEN

DWNG TITLE : AS GIVN


DWNG NO. : 06

D H I V E S H I  
 CONSTRUCTION &  
 CONSULTANCY



Project Management,  
 Building Cost Estimating,  
 Building Design,  
 Construction &  
 Consultancy



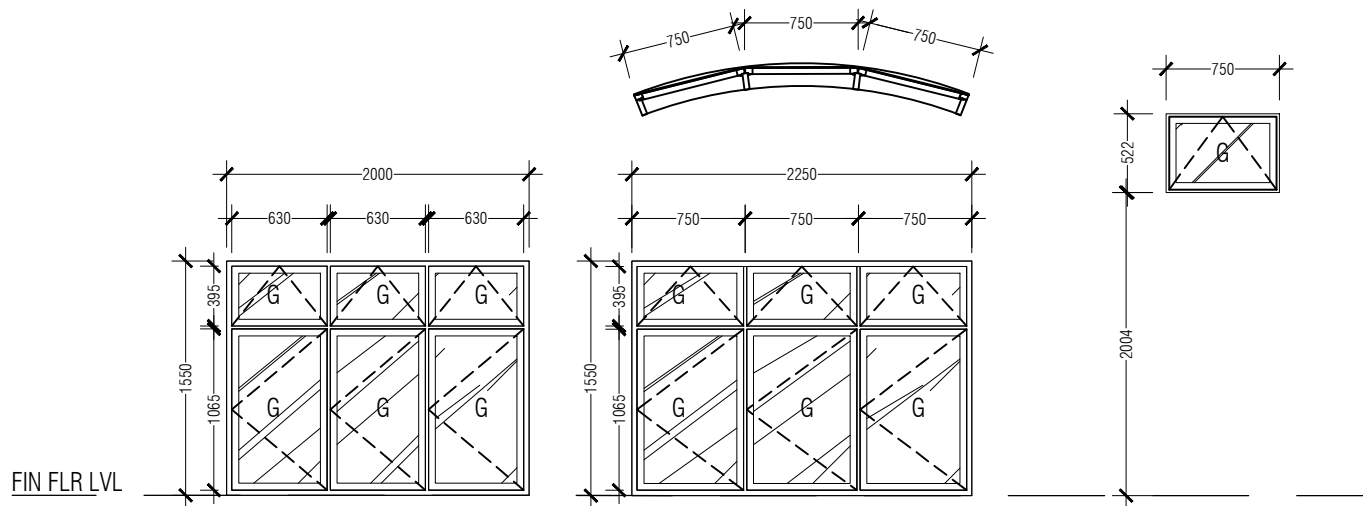

FIN FLR LVL

TYPE	WINDOW W1	WINDOW W2	VENTILATOR V1
FRAME	ALUMINIUM	ALUMINIUM	ALUMINIUM
FINISHING	POWDER COAT	POWDER COAT	POWDER COAT
GLAZING	6MM THICK CLEAR GLASS	6MM THICK CLEAR GLASS	6MM THICK CLEAR GLASS
OPEN AREA			

## DOORS & WINDOWS SCHEDULE 2

SCALE - 1:50

### KEY

- G - GLASS
- TG - TEMPERED GLASS
- FAL - FIXED ALUMINIUM LOUVERS
- T - TIMBER
- GL - GLASS LOUVERS
- A - ALUMINIUM

REMARKS:

CLIENT:

SECRETARY OF  
DHIDHDHDD COUNCIL

PROJECT:

COUNCIL OFFICE  
EXTENSION  
H/A DHIDHDHDD

DESIGNERS:

RASHEED  
ARCHITECTURAL CHECKER:

STRUCTURAL ENGINEER & CHECKER:

SCALE : AS GIVEN


DWNG TITLE : AS GIVN

DWNG NO. : 07

D H I V E S H I  
CONSTRUCTION &  
CONSULTANCY



Project Management,  
Building Cost Estimating,  
Building Design,  
Construction &  
Consultancy

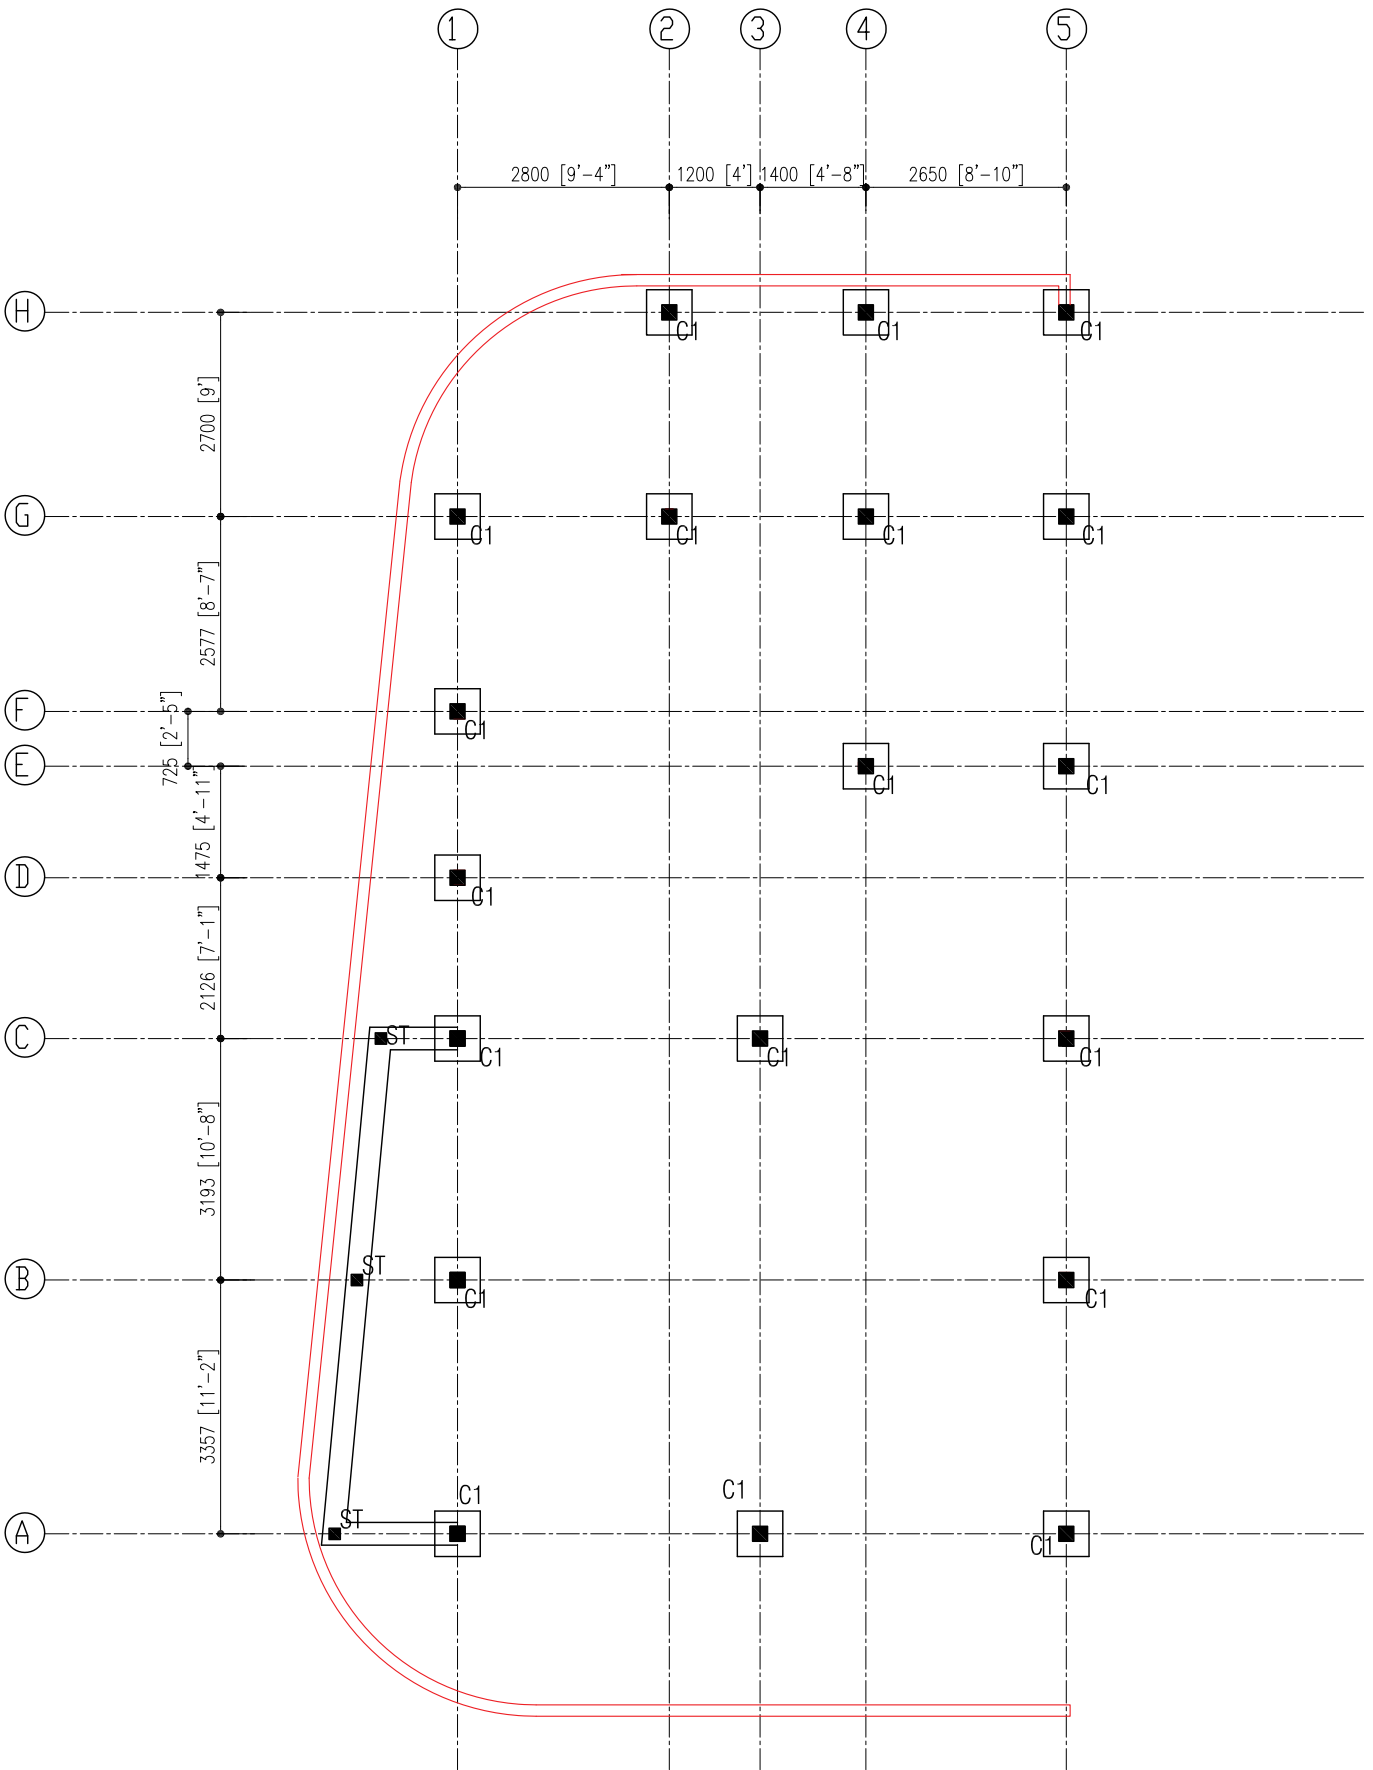

COLUMN PLAN  
SCALE 1:100

REMARKS:

CLIENT:

SECRETARY OF

DHHDHDD COUNCIL

PROJECT:

COUNCIL OFFICE

EXTENSION

HA DHHDHDD

DESIGNERS:

DASHED

ARCHITECTURAL CHECKER

STRUCTURAL ENGINEER & CHECKER

SCALE : AS GIVEN


DWG TITLE : AS GIVEN

DWG NO. : 08



D H I V E S H I  
CONSTRUCTION &  
CONSULTANCY

Project Management,  
Building Cost Estimating,  
Construction &  
Consultancy

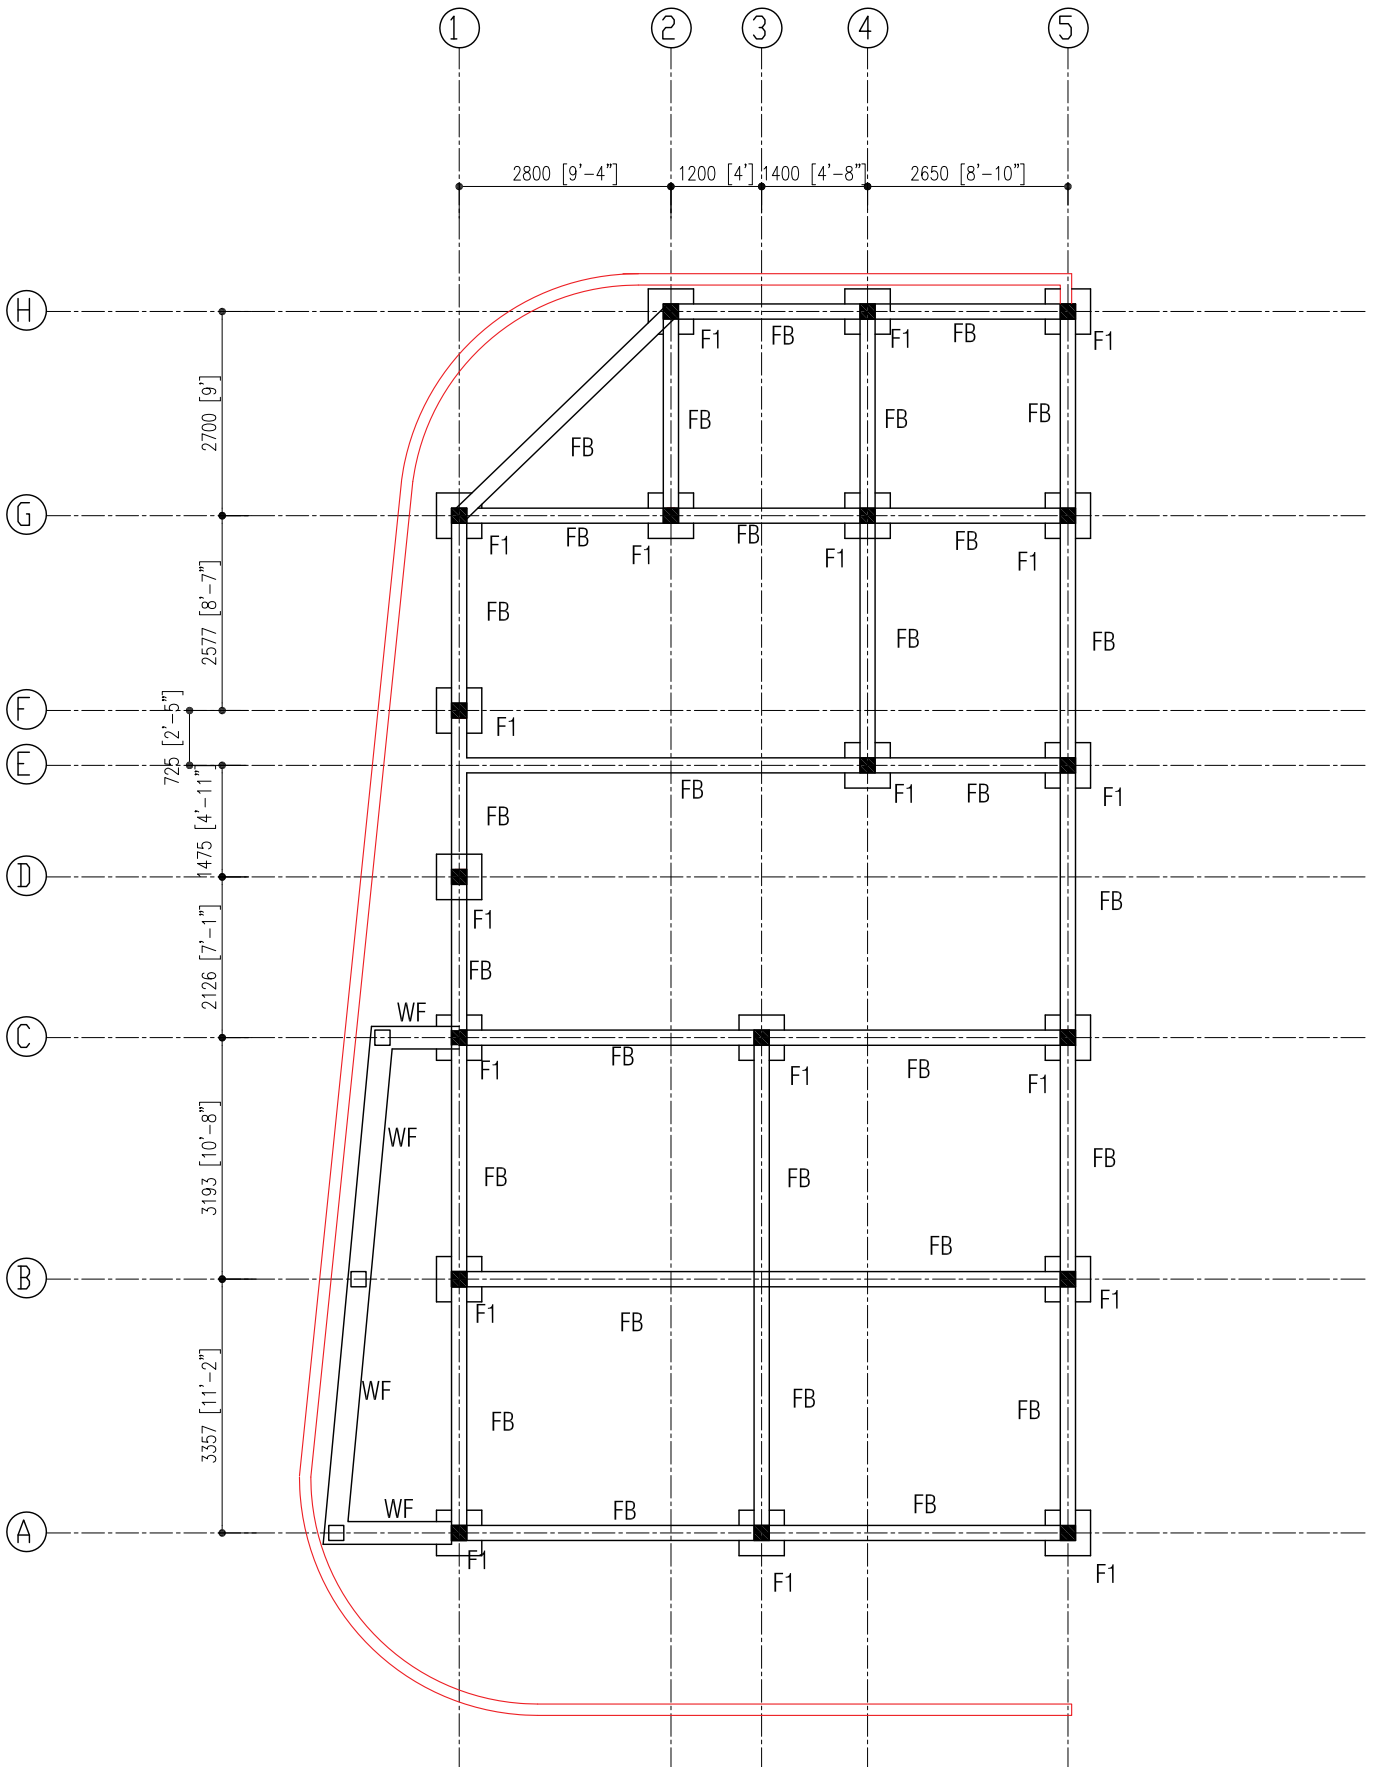

# FOUNDATION PLAN

SCALE 1:100

REMARKS:

CLIENT:

SECRETARY OF

DHAHDHOD COUNCIL

PROJECT:

COUNCIL OFFICE  
EXTENSION  
HA DHAHDHOD

DESIGNERS:

ASABED


ARCHITECTURAL CHECKER

STRUCTURAL ENGINEER & CHECKER

SCALE : AS GIVEN

DWG TITLE : AS GIVEN

DWG NO. : 09

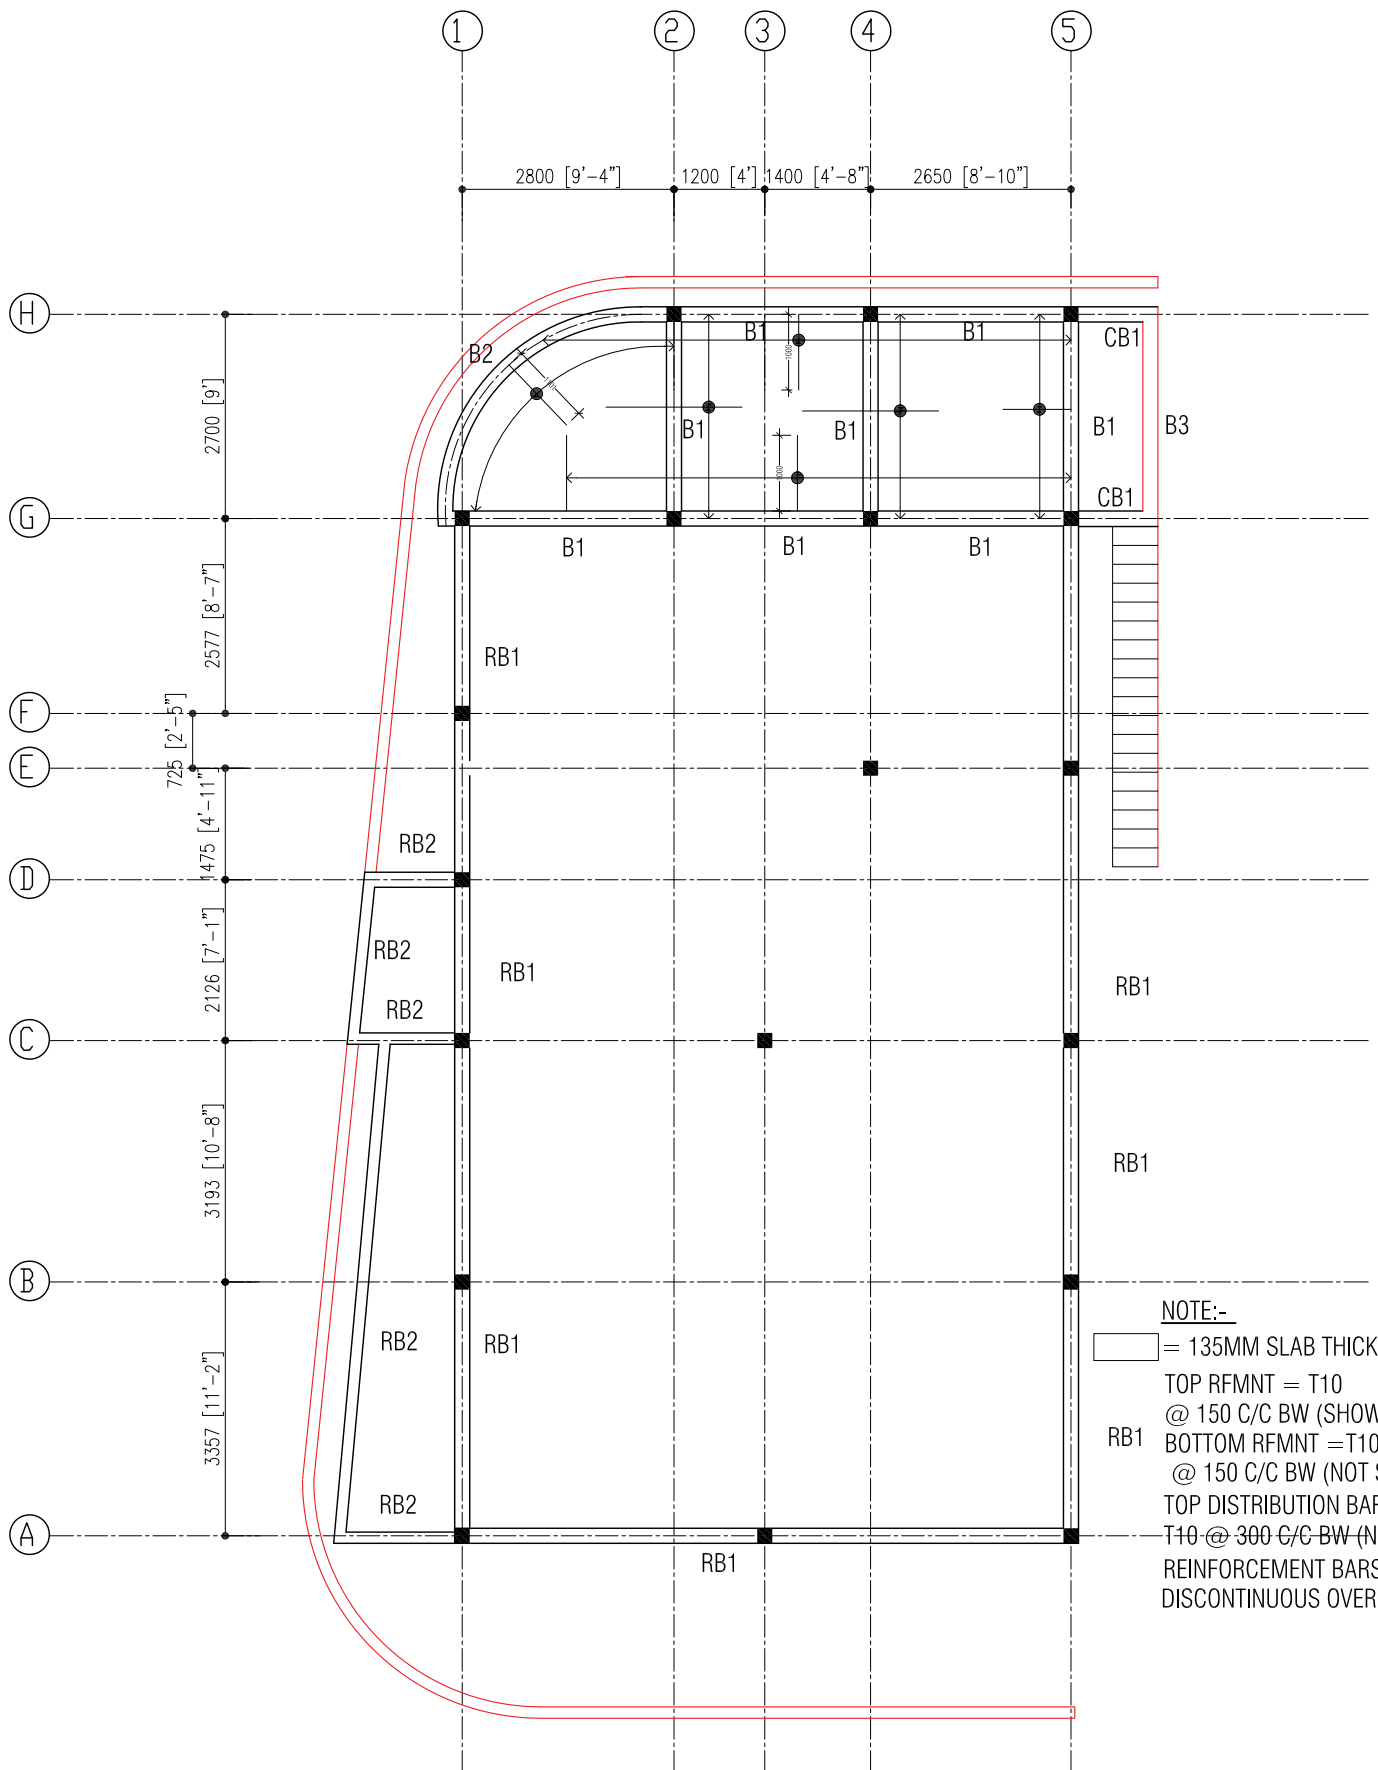

**NOTE:-**  
 [Symbol] = 135MM SLAB THICK SLAB  
 TOP RFMNT = T10  
 @ 150 C/C BW (SHOWN)  
 RB1 BOTTOM RFMNT = T10  
 @ 150 C/C BW (NOT SHOWN)  
 TOP DISTRIBUTION BARS = T10  
 T10 @ 300 C/C BW (NOT SHOWN)  
 REINFORCEMENT BARS WILL BE DISCONTINUOUS OVER VOIDS.

ROOF LEVEL-1/BEAM PLAN  
 SCALE 1:100

**D H I V E S H I**  
 CONSTRUCTION &  
 CONSULTANCY

Project Management,  
 Building Cost Estimating,  
 Consulting Engineers &  
 Consultancy

CLIENT:  
 SECRETARY OF  
 DHHDHDD COUNCIL


PROJECT:  
 COUNCIL OFFICE  
 EXTENSION  
 HA DHHDHDD

DESIGNERS:  
 RASHEED  
 ARCHITECTURAL CHECKER

STRUCTURAL ENGINEER & CHECKER

SCALE : AS GIVEN  
 DWNG TITLE : AS GIVEN  
 DWNG NO. : 10

REMARKS:

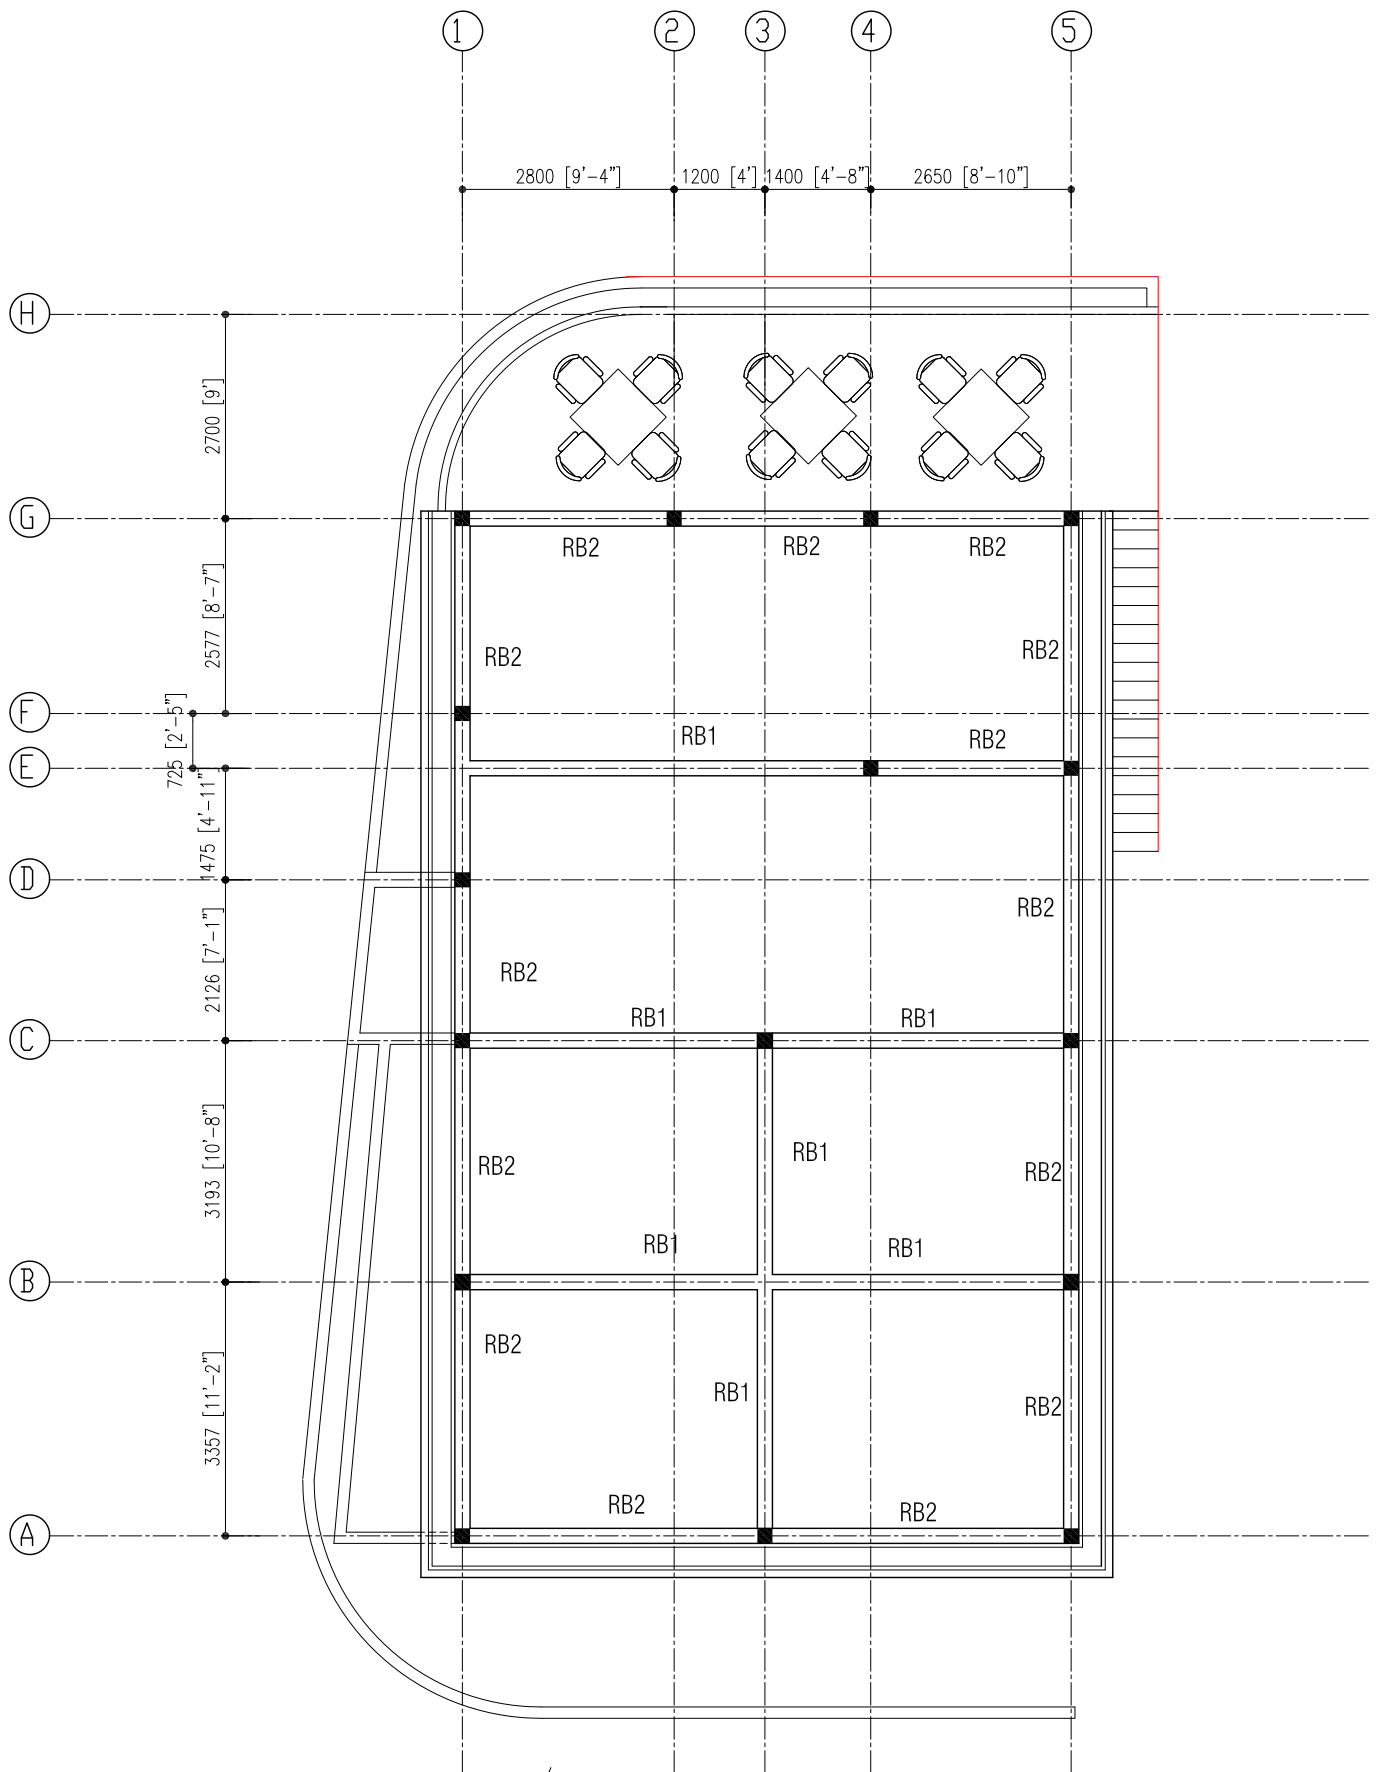

ROOF LEVEL -2/BEAM PLAN  
SCALE 1:100

REMARKS:

CLIENT:

SECRETARY OF

DHHDHDD COUNCIL

PROJECT:

COUNCIL OFFICE  
EXTENSION  
HA DHHDHDD

DESIGNERS:

RASHEED  
ARCHITECTURAL CHECKER


STRUCTURAL ENGINEER & CHECKER

SCALE : AS GIVEN

DWG TITLE : AS GIVEN

DWG NO. : 11



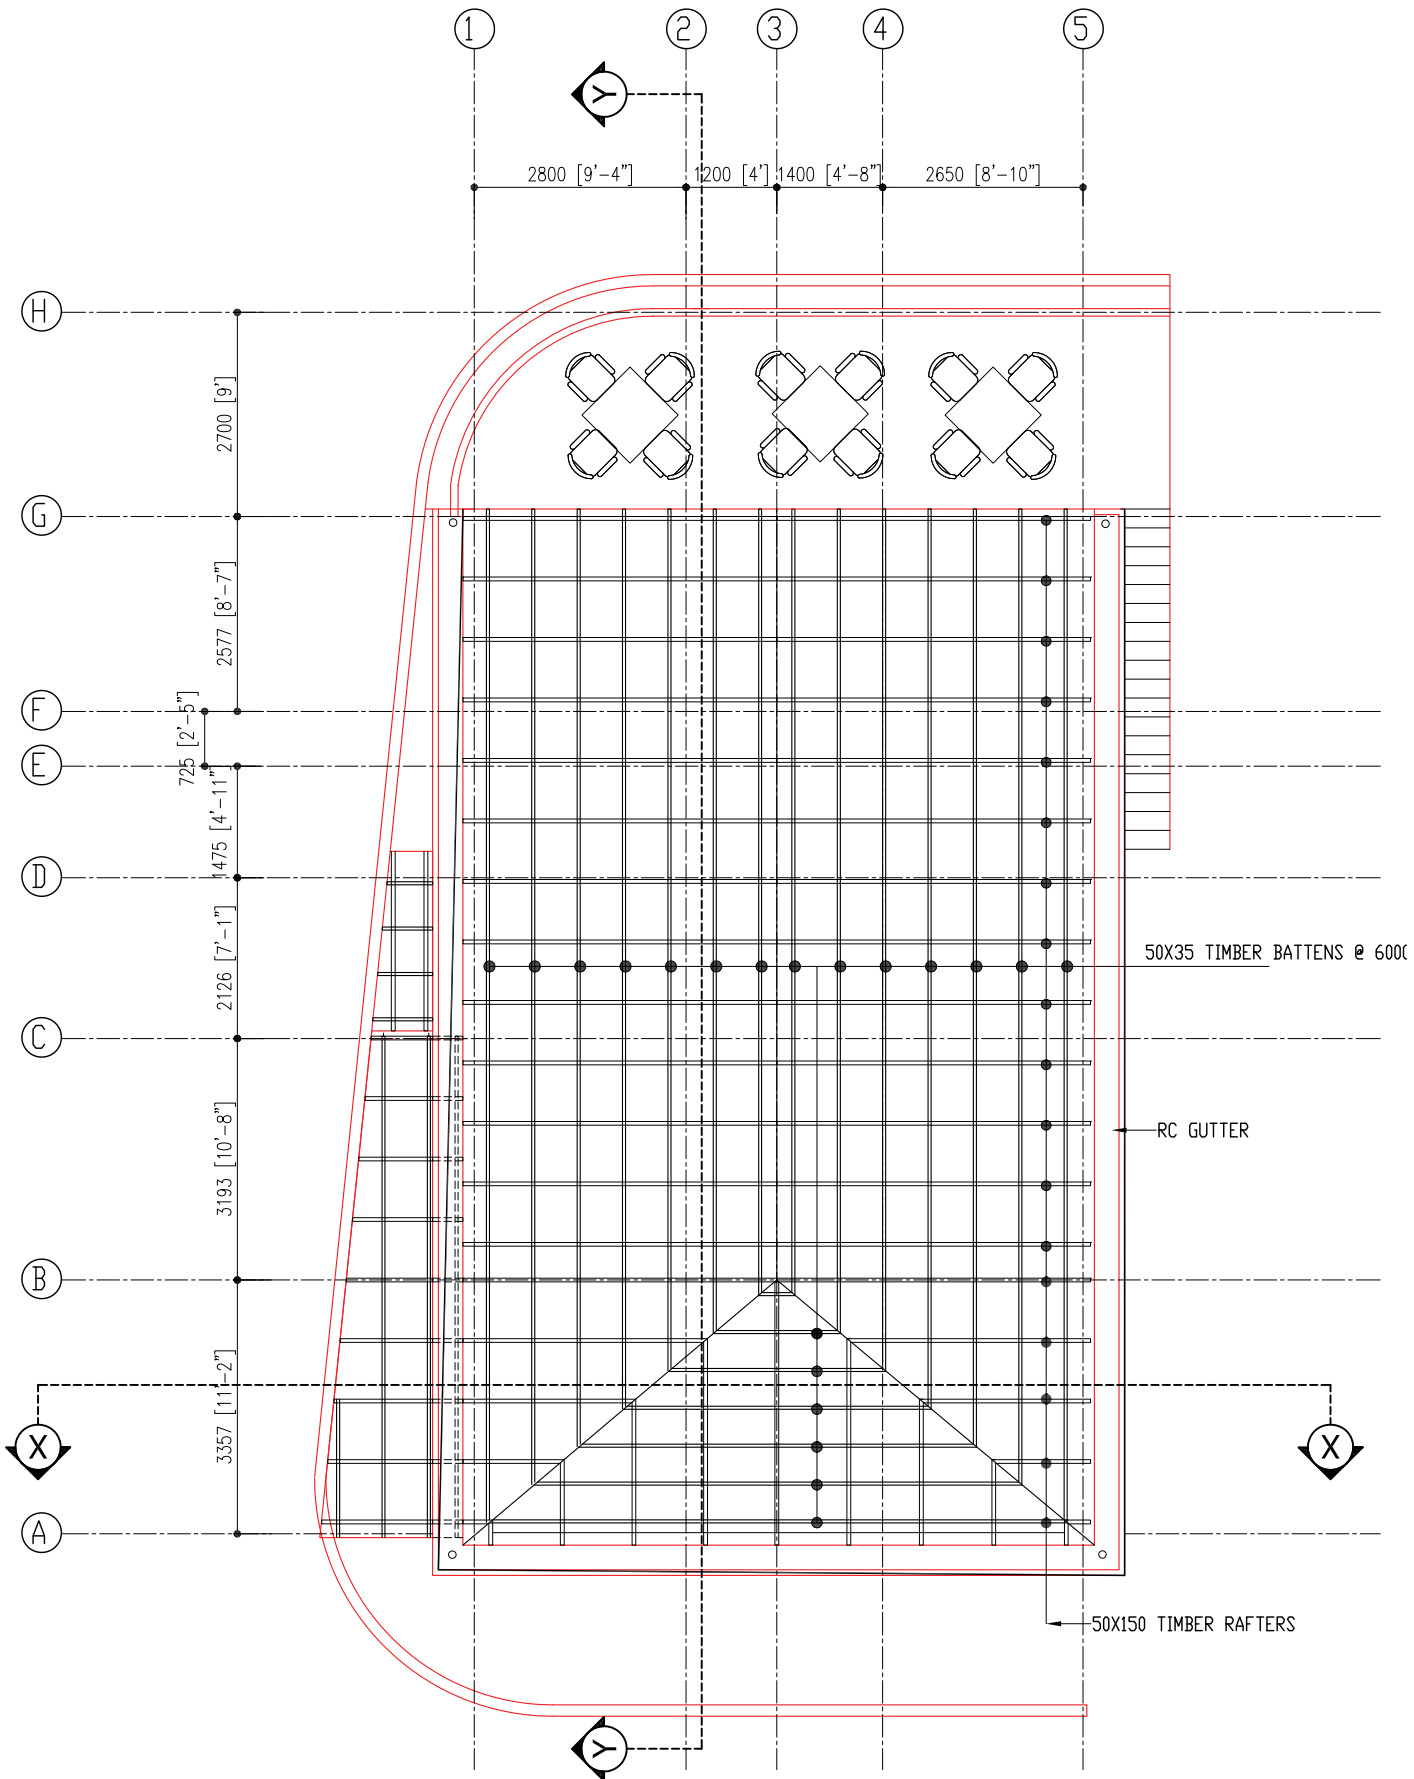

ROOF STRUCTURE  
SCALE 1:100

REMARKS:

CLIENT:

SECRETARY OF

DHHDHDD COUNCIL

PROJECT:

COUNCIL OFFICE

EXTENSION

HA DHHDHDD

DESIGNERS:

RAKED

ARCHITECTURAL CHECKER

STRUCTURAL ENGINEER & CHECKER

SCALE : AS GIVEN


DWG TITLE : AS GIVEN

DWG NO. : 12




D. H. LIVESEY & CO.  
CONSTRUCTION &  
CONSULTANCY

Project Management,  
Building Cost Estimating,  
Construction Supervision &  
Consultancy

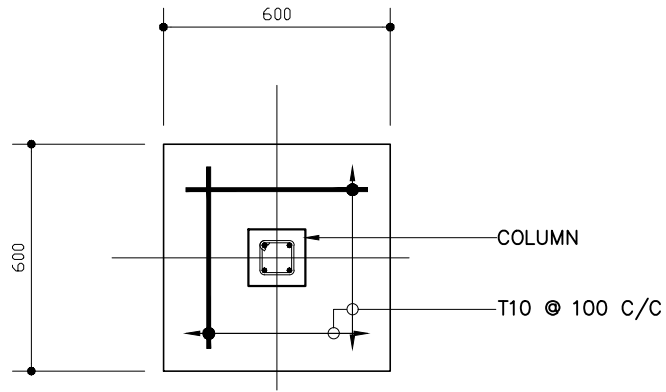


**PLAN (F1)**

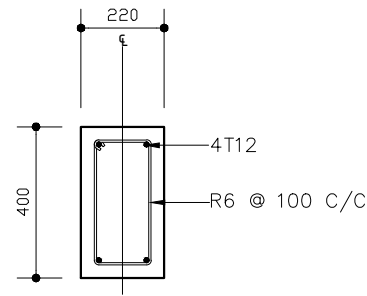

**FB**

**FOUNDATION BEAM (FB) DETAILS**


SCALE 1: 20

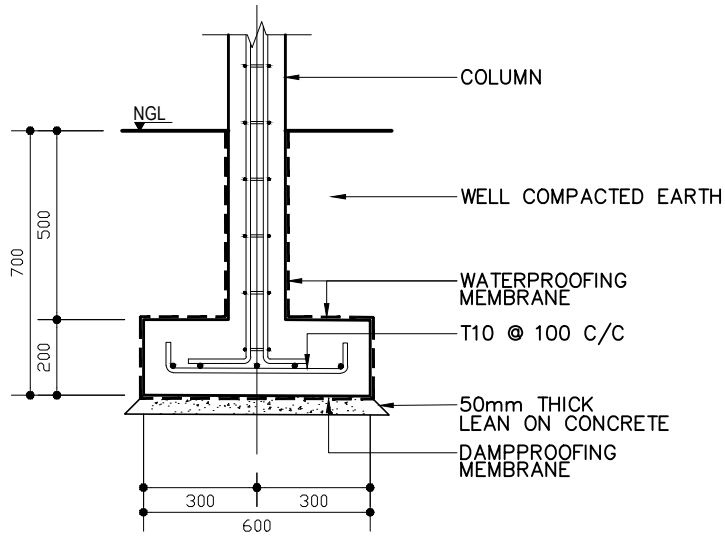

**SECTION (F1)**

**FOOTING (F) DETAILS**

SCALE 1: 20

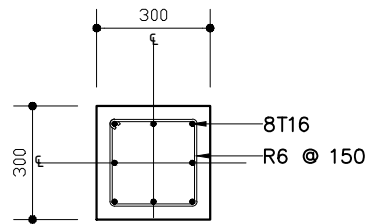

**WF**

**WALL FOOTING (WF) DETAIL**

SCALE 1: 20

REMARKS:

CLIENT:

SECRETARY OF  
DHIDHDHDD COUNCIL

PROJECT:

COUNCIL OFFICE  
EXTENSION  
H.A DHIDHDHDD

DESIGNERS:

RASHIED  
ARCHITECTURAL CHECKER:

STRUCTURAL ENGINEER & CHECKER:

SCALE : AS GIVEN



DWNG TITLE : AS GIVN

DWNG NO. : 13


D H I V E S H I  
CONSTRUCTION &  
CONSULTANCY




Project Management,  
Building Cost Estimating,  
Building Design,  
Construction &  
Consultancy

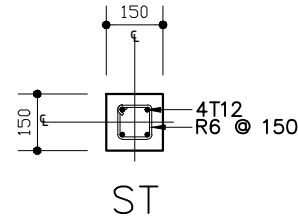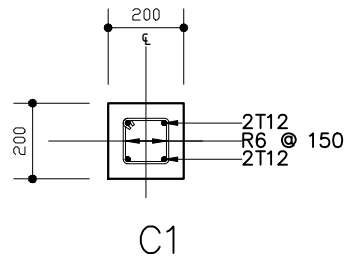


**COLUMN (C) DETAILS**  
SCALE 1: 20

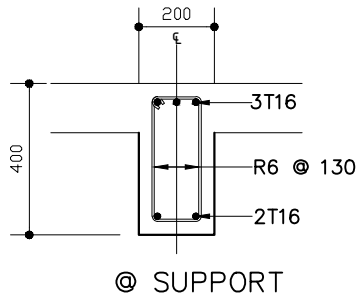


B1

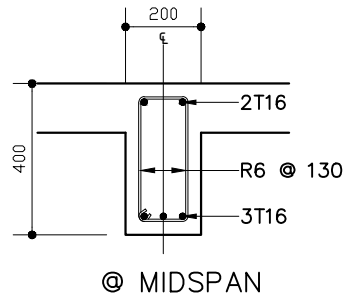


@ MIDSPAN

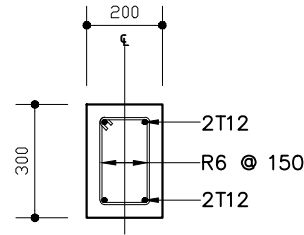

B2

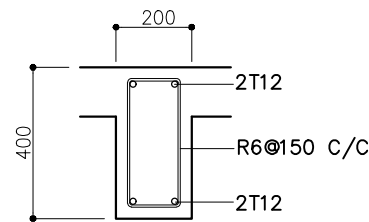

B3

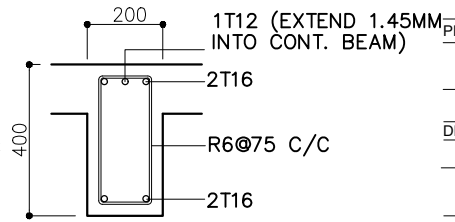

CB1

**BEAM (B) DETAILS**  
SCALE 1: 20

REMARKS:

CLIENT:

SECRETARY DF  
DHIDHDHOD COUNCIL

PROJECT:

COUNCIL OFFICE  
EXTENSION  
H.A DHIDHDHOD

DESIGNERS:

RASHEED

ARCHITECTURAL CHECKER:

STRUCTURAL ENGINEER & CHECKER:

SCALE : AS GIVEN

DWNG TITLE : AS GIVN


DWNG NO. : 14

D H I V E S H I  
CONSTRUCTION &  
CONSULTANCY




Project Management,  
Building Cost Estimating,  
Building Design,  
Construction &  
Consultancy




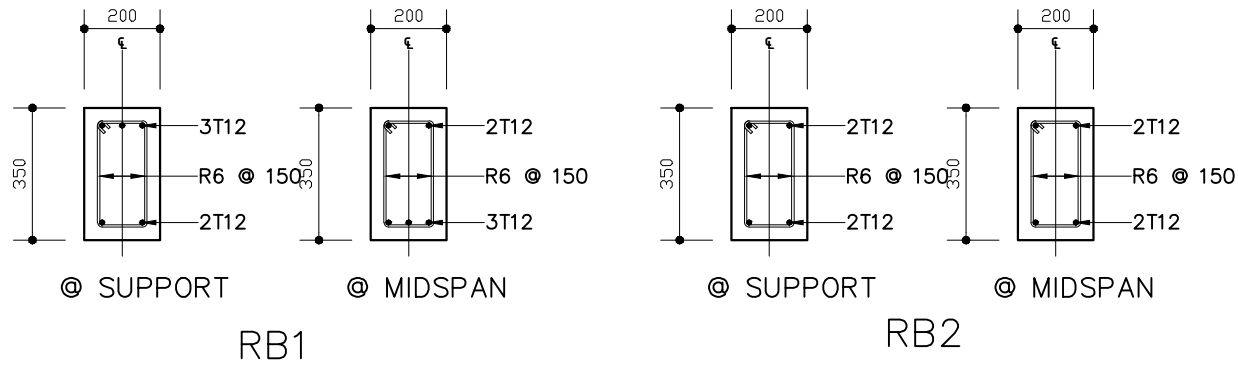

**ROOF BEAM (RB) DETAILS**  
SCALE 1: 20

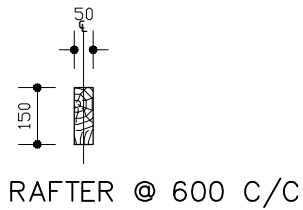

**ROOF MEMBER DETAIL**  
SCALE 1: 20

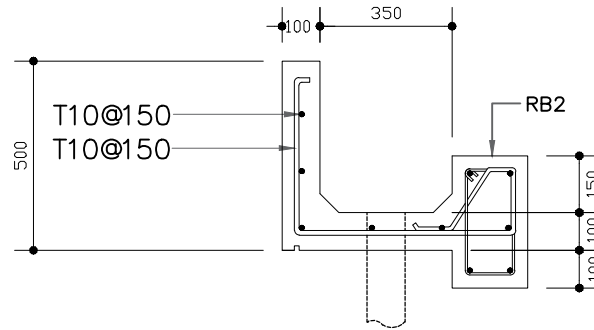

**GUTTER DETAIL**  
SCALE 1: 20

REMARKS:

CLIENT:

SECRETARY OF  
DHIDHDHDD COUNCIL

PROJECT:

COUNCIL OFFICE  
EXTENSION  
H.A. DHIDHDHDD

DESIGNERS:

RASHEED  
ARCHITECTURAL CHECKER:

STRUCTURAL ENGINEER & CHECKER:

SCALE : AS GIVEN


DWNG TITLE : AS GIVN

DWNG NO. : 15


D H I V E S H I  
CONSTRUCTION &  
CONSULTANCY



Project Management,  
Building Cost Estimating,  
Building Design,  
Construction &  
Consultancy

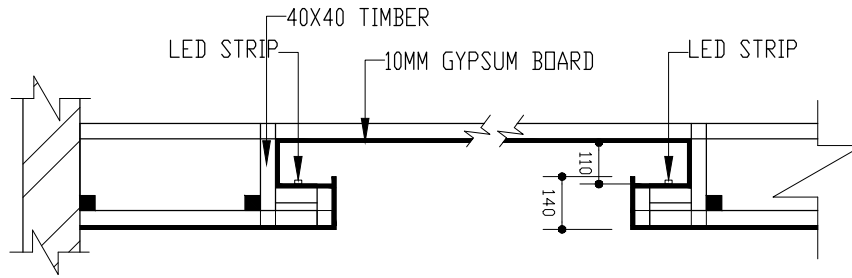

DETAIL 1  
SCALE 1:20

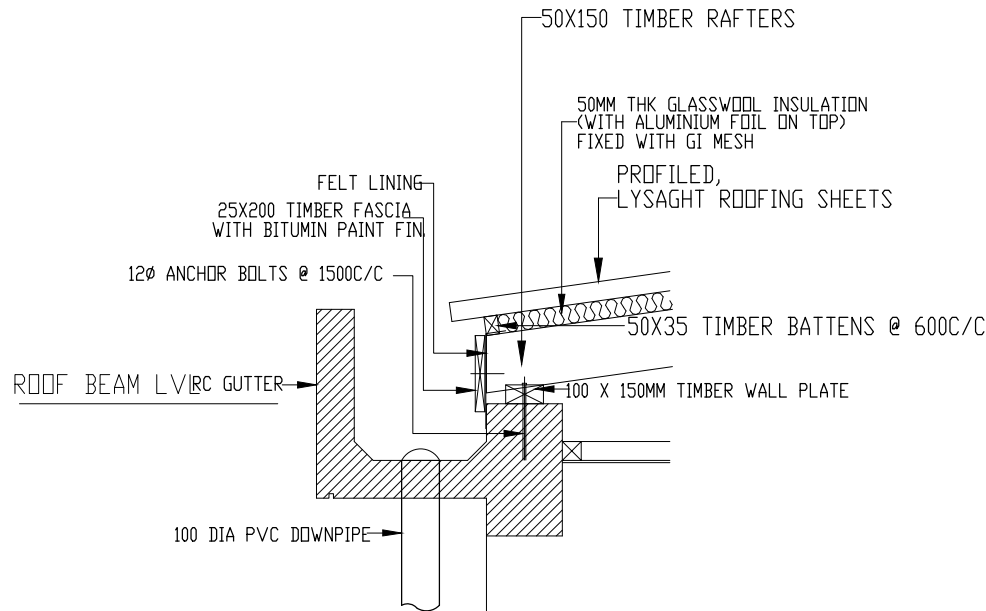

DETAIL 2  
SCALE 1:20

REMARKS:

CLIENT:

SECRETARY OF  
DHIDHDHOO COUNCIL

PROJECT:

COUNCIL OFFICE  
EXTENSION  
H.A. DHIDHDHOO

DESIGNERS:

RASHEED  
ARCHITECTURAL CHECKER

STRUCTURAL ENGINEER & CHECKER

SCALE : AS GIVEN


DWNG TITLE : AS GIVN

DWNG NO. : 16

D H I V E S H I  
CONSTRUCTION &  
CONSULTANCY



Project Management,  
Building Cost Estimating,  
Building Design,  
Construction &  
Consultancy

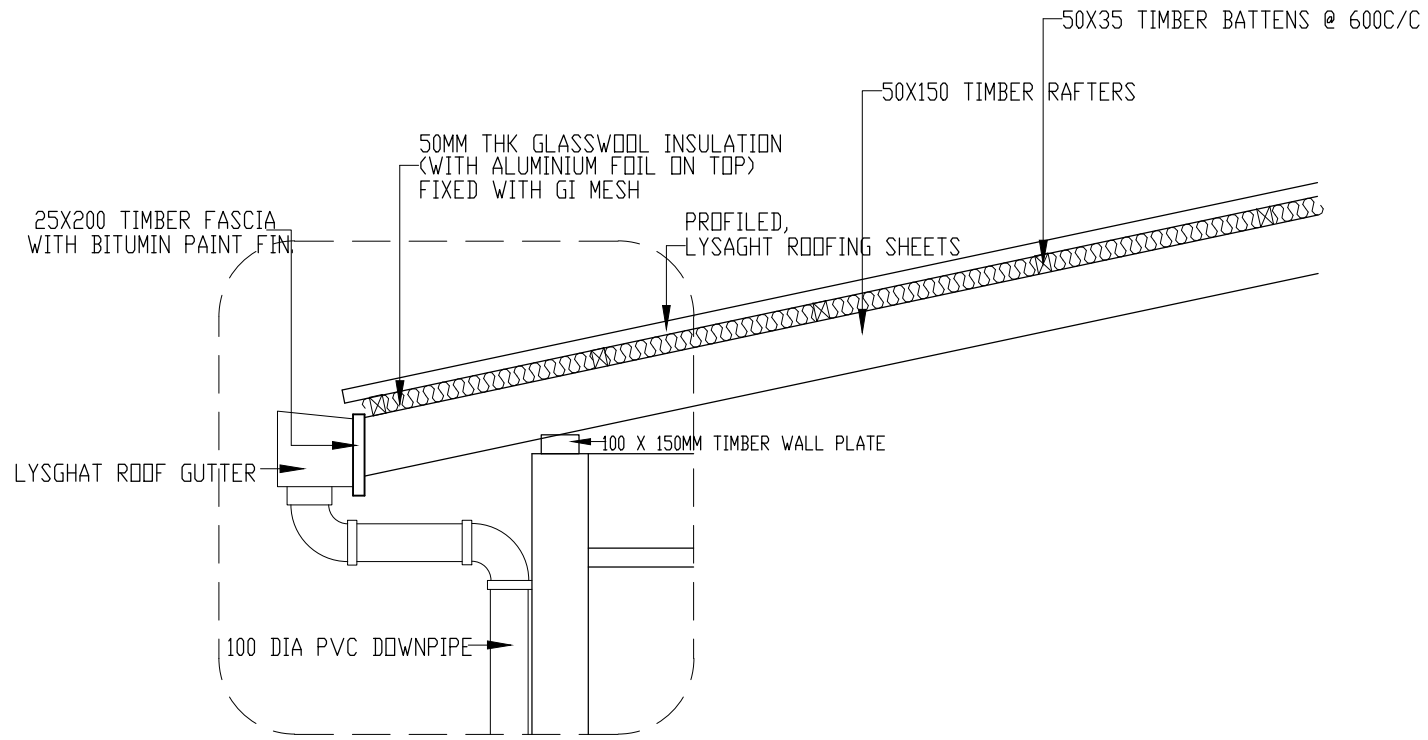

DETAIL 3  
SCALE 1:20

REMARKS:

CLIENT:

SECRETARY OF  
DHIDHDHDD COUNCIL

PROJECT:

COUNCIL OFFICE  
EXTENSION  
H.A DHIDHDHDD

DESIGNERS:

RASHEED  
ARCHITECTURAL CHECKER

STRUCTURAL ENGINEER & CHECKER:

SCALE : AS GIVEN


DWNG TITLE : AS GIVN

DWNG NO. : 17

D H I V E S H I  
CONSTRUCTION &  
CONSULTANCY



Project Management,  
Building Cost Estimating,  
Building Design,  
Construction &  
Consultancy

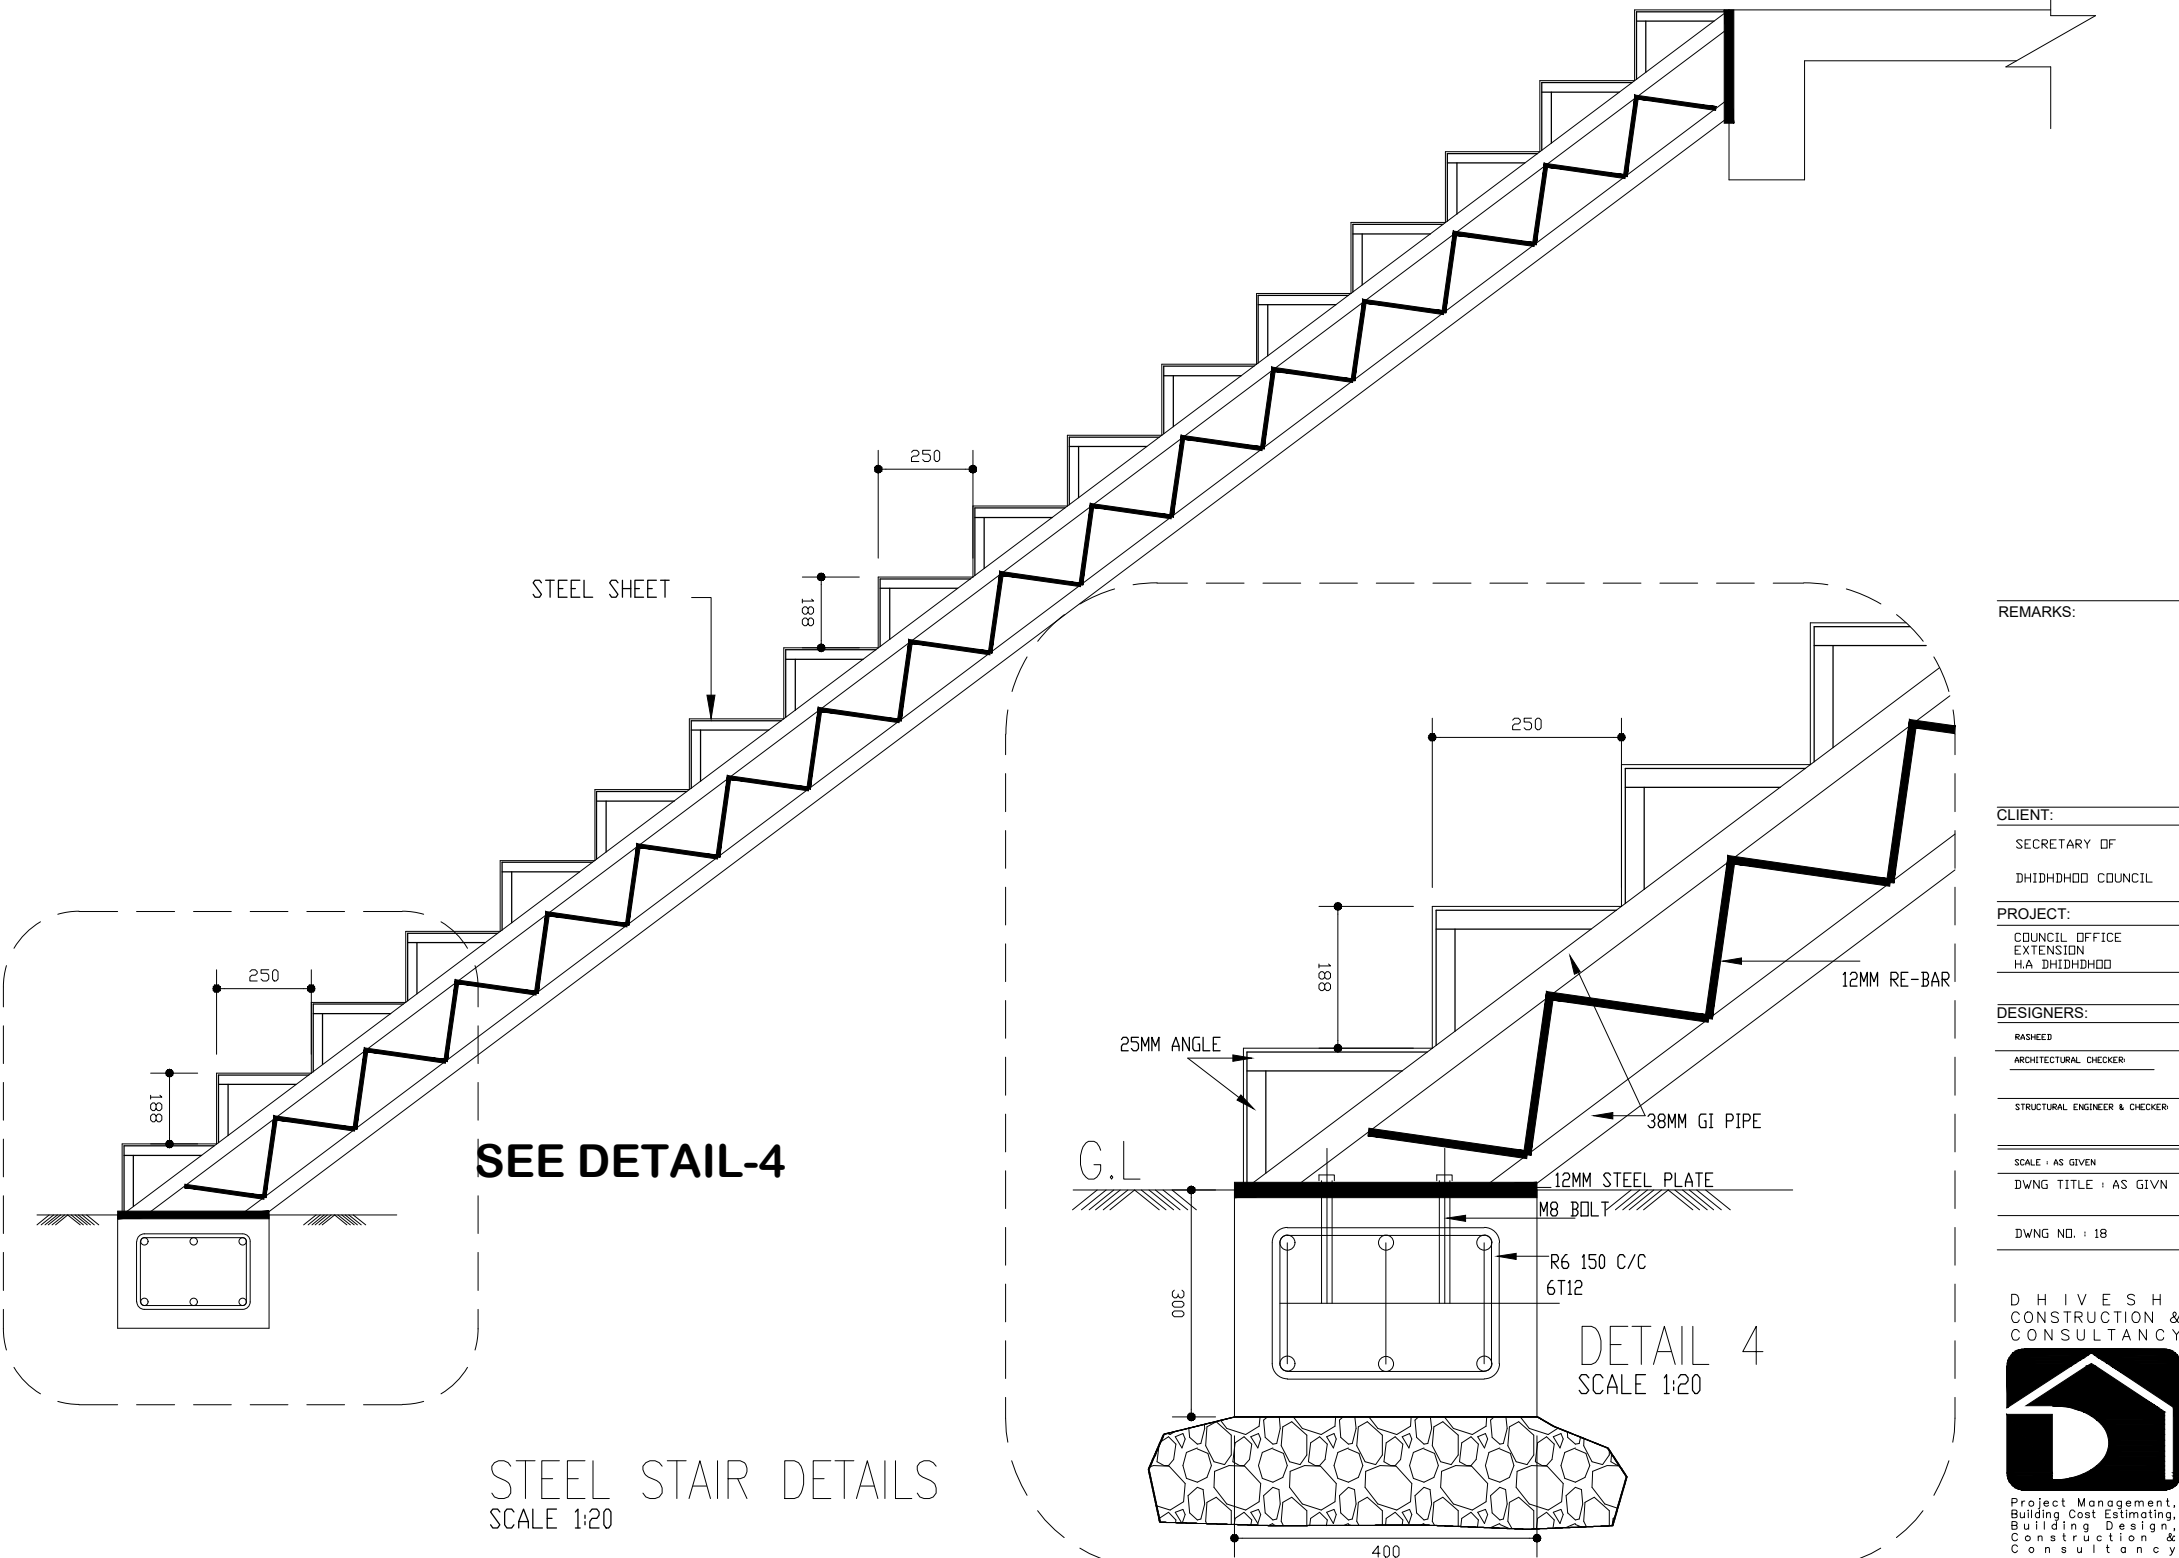

STEEL STAIR DETAILS  
SCALE 1:20

REMARKS:

CLIENT:

SECRETARY OF  
DHIDHDOD COUNCIL

PROJECT:

COUNCIL OFFICE  
EXTENSION  
H.A. DHIDHDOD

DESIGNERS:

RASHEED  
ARCHITECTURAL CHECKER:

STRUCTURAL ENGINEER & CHECKER:

SCALE : AS GIVEN


DWNG TITLE : AS GIVN

DWNG NO. : 18

D H I V E S H I  
CONSTRUCTION &  
CONSULTANCY



Project Management,  
Building Cost Estimating,  
Building Design,  
Construction &  
Consultancy

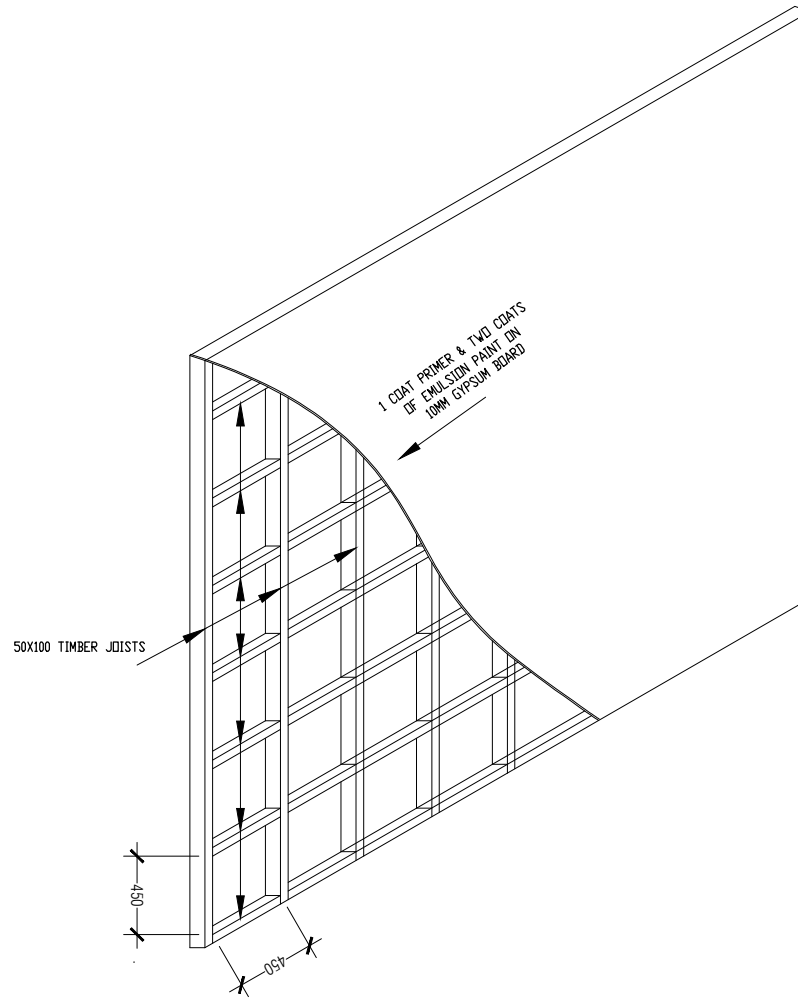

**TYPICAL TIMBER PARTITION WALL**  
**SCALE - 1:50**

REMARKS:

CLIENT:

SECRETARY OF  
 DHIDHDHDD COUNCIL

PROJECT:

COUNCIL OFFICE  
 EXTENSION  
 H.A DHIDHDHDD

DESIGNERS:

RASHEED

ARCHITECTURAL CHECKER

STRUCTURAL ENGINEER & CHECKER:

SCALE : AS GIVEN


DWNG TITLE : AS GIVN

DWNG NO. : 19

D H I V E S H I  
 CONSTRUCTION &  
 CONSULTANCY



Project Management,  
 Building Cost Estimating,  
 Building Design,  
 Construction &  
 Consultancy

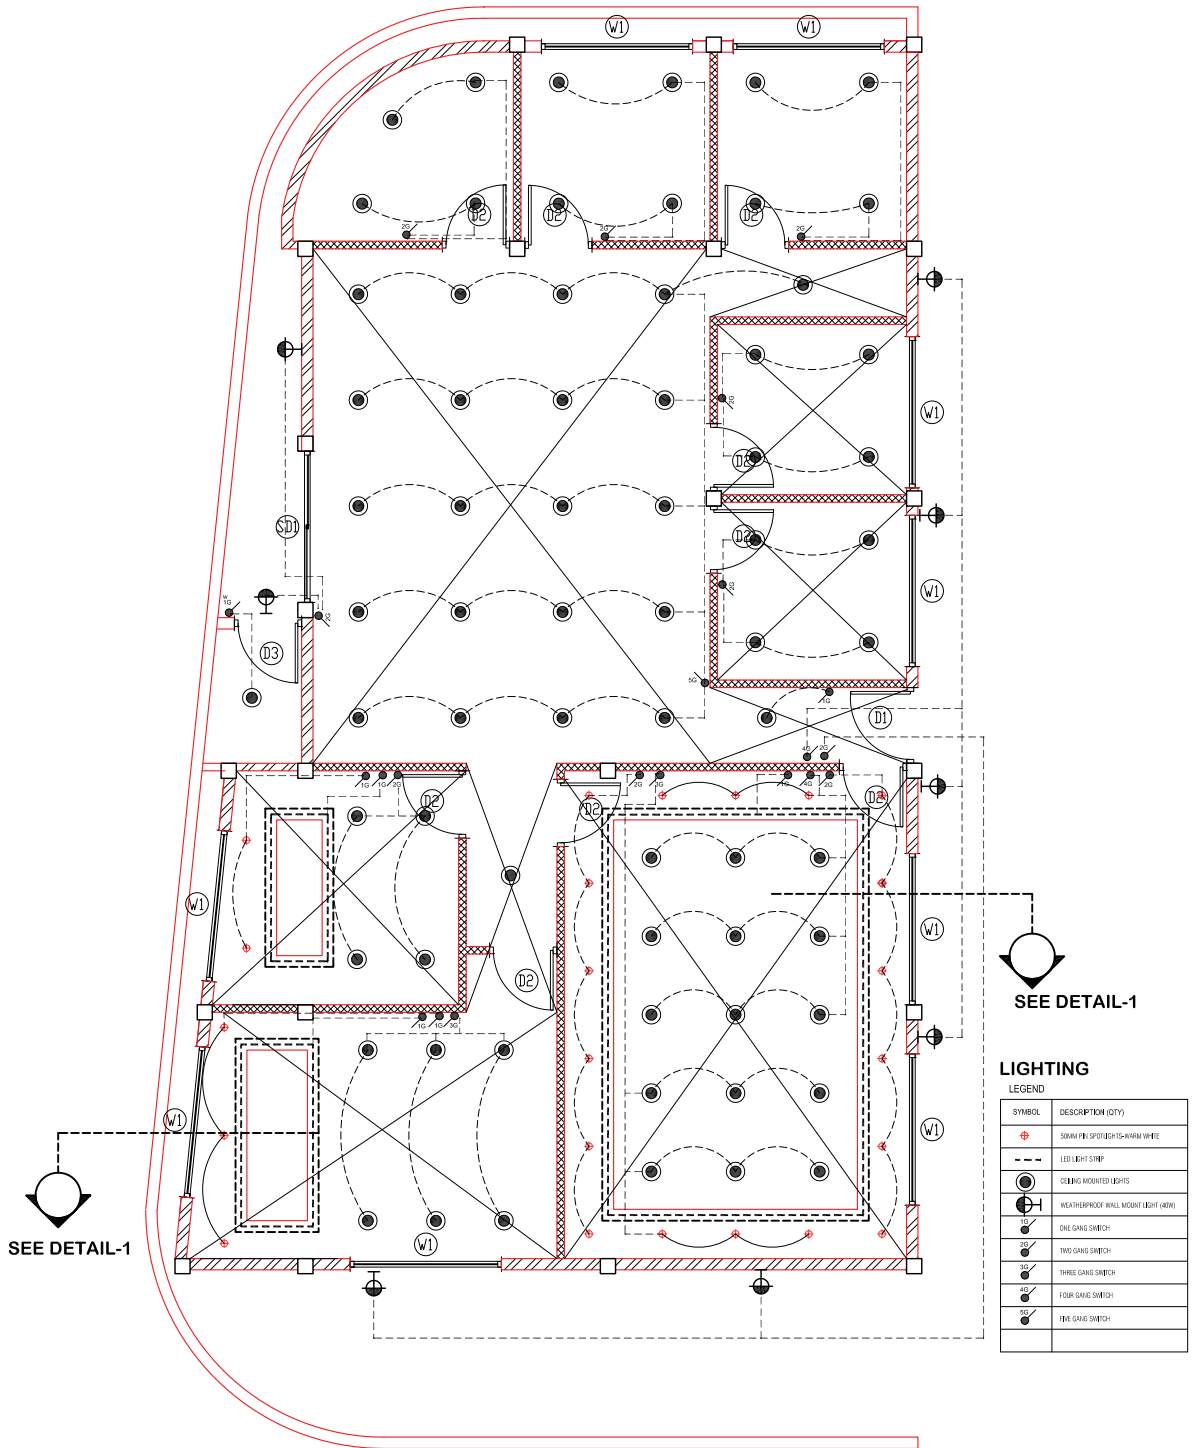

REFLECTIVE CEILING/LIGHTING PLAN  
 GROUND FLOOR  
 SCALE 1:100

**LIGHTING**

LEGEND

SYMBOL	DESCRIPTION (QTY)
⊕	SPRING SPOTLIGHTS-WARM WHITE
- - -	LED LIGHT STRIP
○	CEILING MOUNTED LIGHTS
⊕	WEATHERPROOF WALL MOUNT LIGHT (40W)
1G	ONE GANG SWITCH
2G	TWO GANG SWITCH
3G	THREE GANG SWITCH
4G	FOUR GANG SWITCH
5G	FIVE GANG SWITCH

REMARKS:

CLIENT:

SECRETARY OF  
 DHHDHDD COUNCIL

PROJECT:

COUNCIL OFFICE  
 EXTENSION  
 H.A. DHHDHDD

DESIGNERS:

RASHED  
 ARCHITECTURAL CHECKER

STRUCTURAL ENGINEER & CHECKER

SCALE : AS GIVEN


DWG TITLE : AS GIVEN

DWG NO. : 20

D H I V E S H I  
 CONSTRUCTION &  
 CONSULTANCY



Project Management,  
 Building Cost Estimating,  
 Quantity Surveying,  
 Consultancy

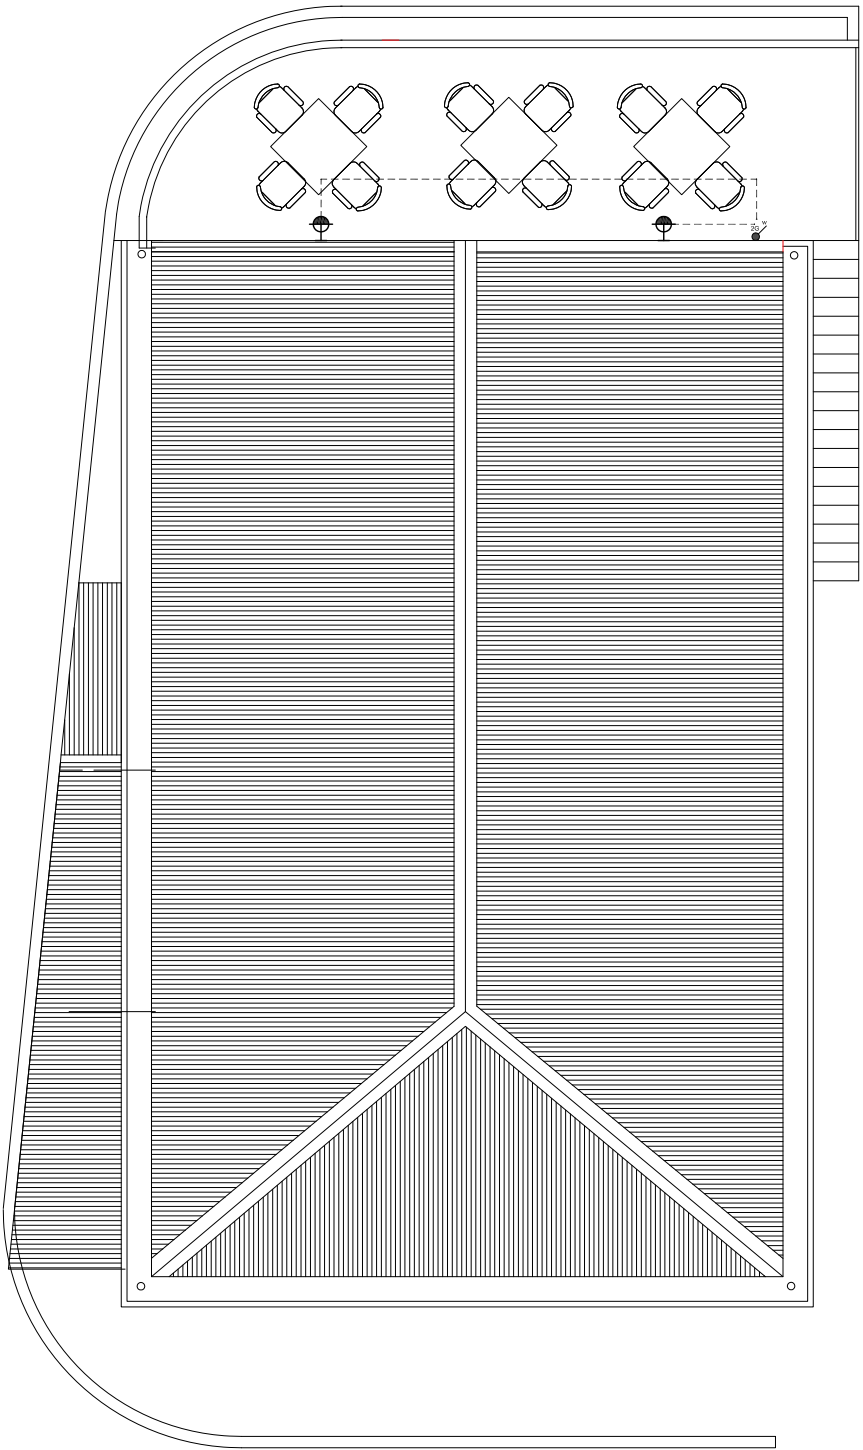

# LIGHTING PLAN TERRACE FLOOR

REMARKS:

CLIENT:

SECRETARY DF

DHHDHDD COUNCIL

PROJECT:

COUNCIL OFFICE

CA ENDDHDD

HA DHHDHDD

DESIGNERS:

RASHEB

ARCHITECTURAL CHECKER

STRUCTURAL ENGINEER & CHECKER


SCALE : AS GIVEN

DWG TITLE : AS GIVEN

DWG NO. : 21



D H I V E S H I  
CONSTRUCTION &  
CONSULTANCY  
Project Management,  
Building Cost Estimating,  
Building Design,  
Construction

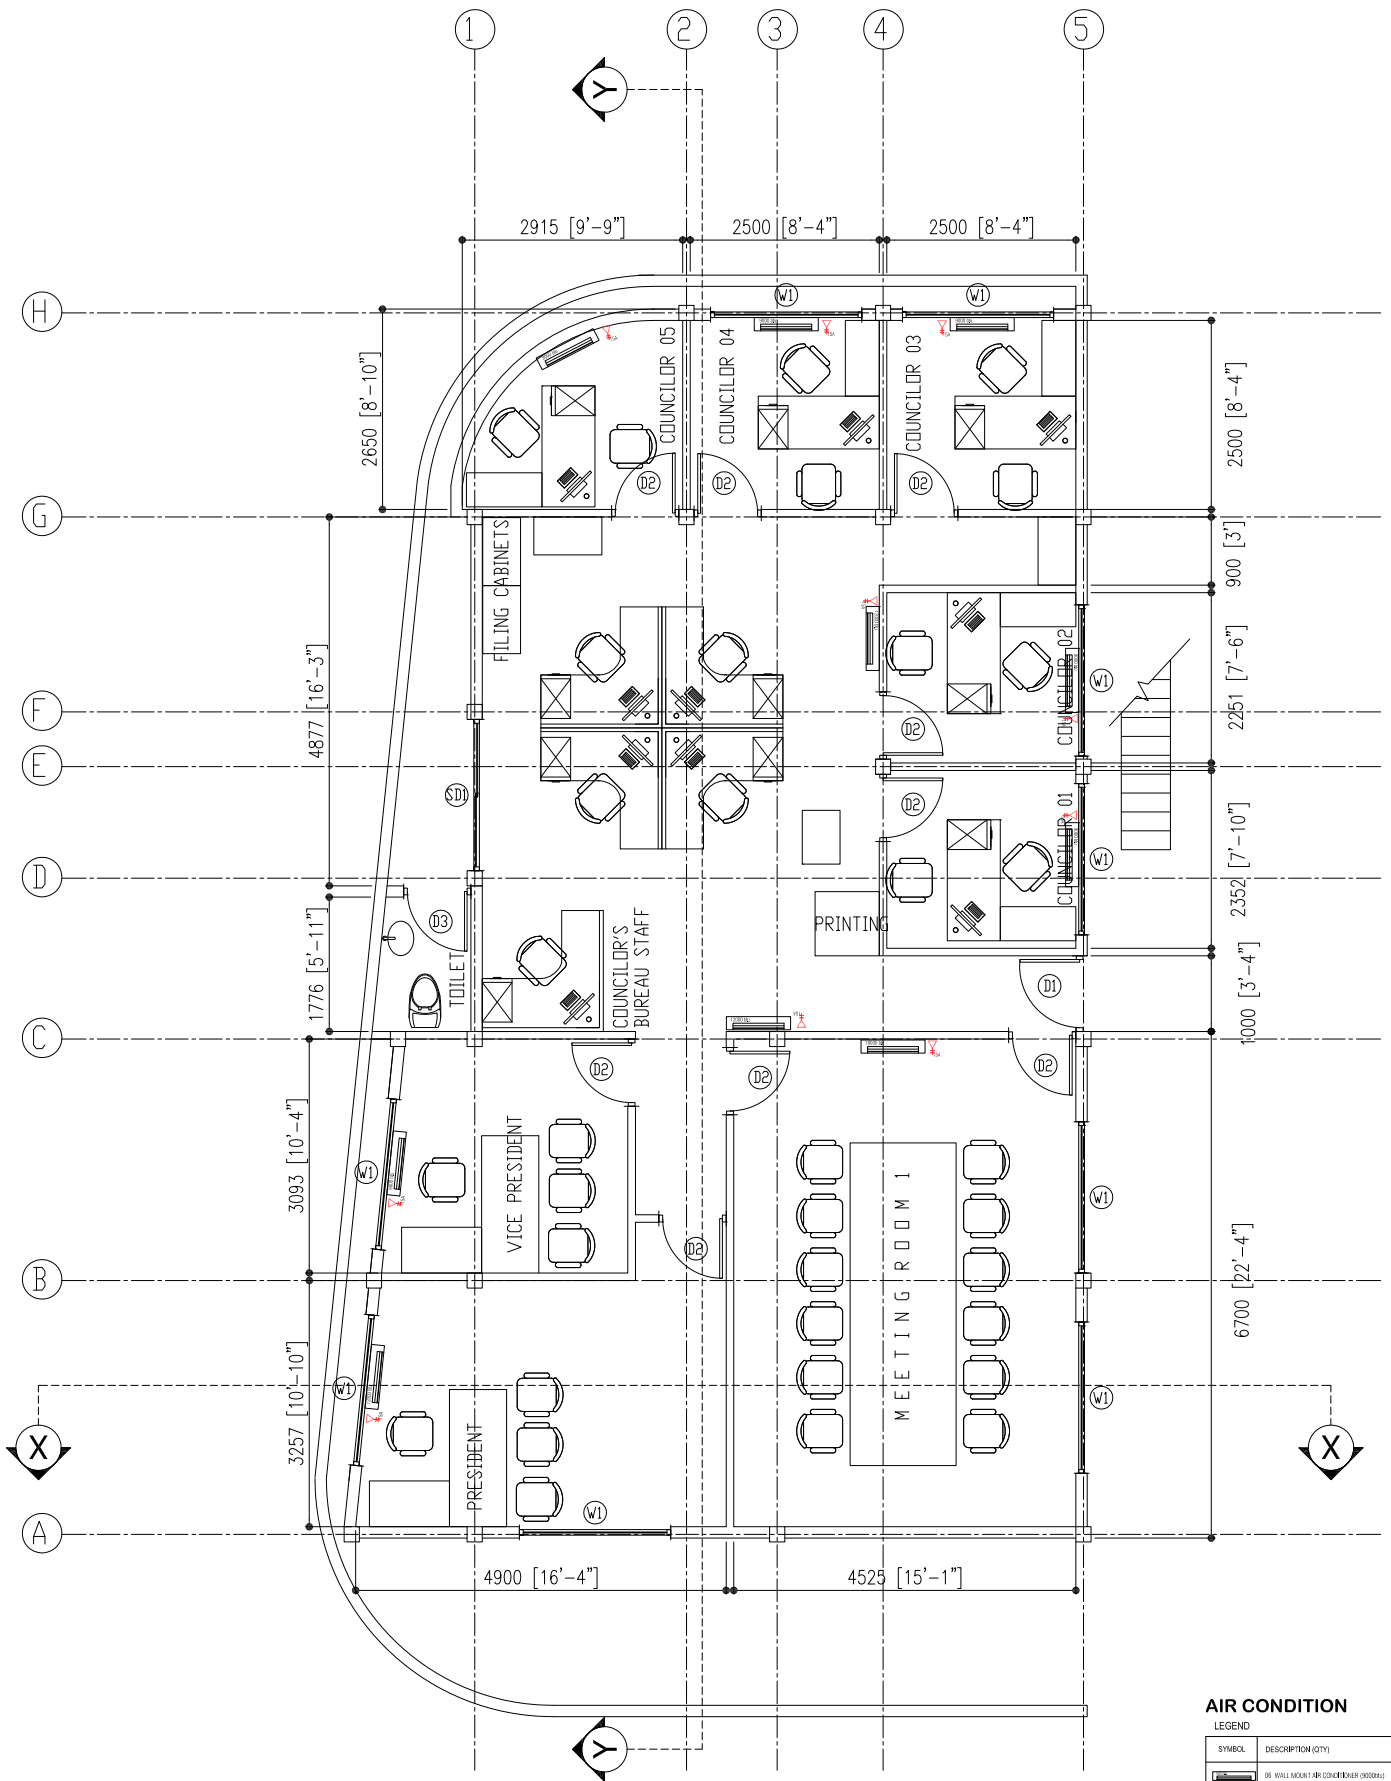

# AC & AC SOCKET LAYOUT

SCALE 1:100

### AIR CONDITION

LEGEND

SYMBOL	DESCRIPTION (QTY)
	06 WALL MOUNT AIR CONDITIONER (3000W)
	03 WALL MOUNT AIR CONDITIONER (2000W)
	01 WALL MOUNT AIR CONDITIONER (1800W)
	10 18A SOCKET OUTLETS

REMARKS:

CLIENT:

SECRETARY OF

DHHDHDD COUNCIL

PROJECT:

COUNCIL OFFICE

EXTENSION

HA DHHDHDD

DESIGNERS:

RANRED

ARCHITECTURAL CHECKER

STRUCTURAL ENGINEER & CHECKER

SCALE : AS GIVEN

DWG TITLE : AS GIVEN


DWG NO. : 22

D H L V E S H I  
CONSTRUCTION &  
CONSULTANCY



Project Management,  
Building Cost Estimating,  
Construction &  
Consultancy



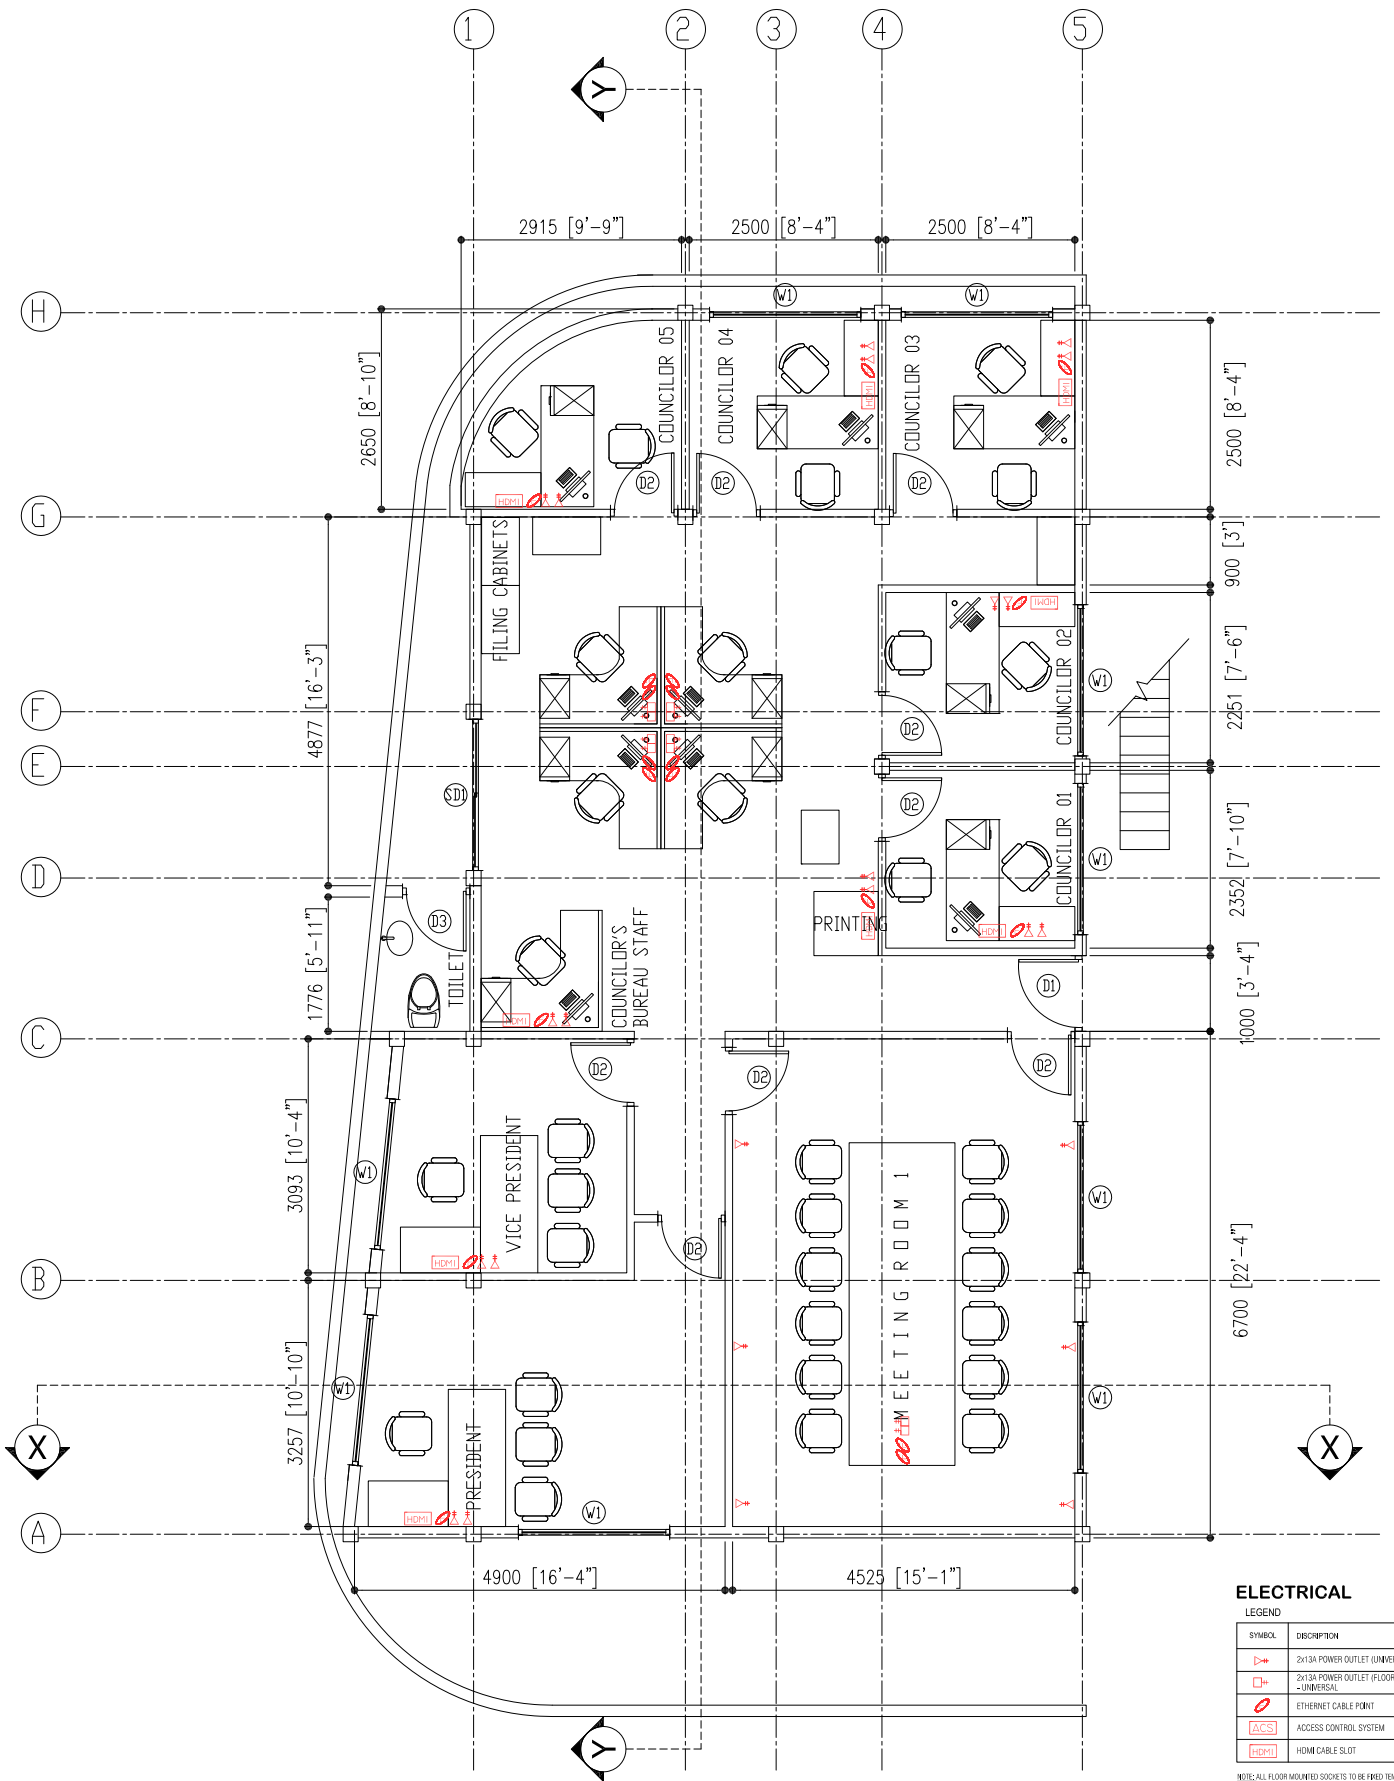

**ELECTRICAL**

LEGEND

SYMBOL	DESCRIPTION
	2x13A POWER OUTLET (UNIVERSAL)
	2x13A POWER OUTLET (FLOOR MOUNT) - UNIVERSAL
	ETHERNET CABLE POINT
	ACCESS CONTROL SYSTEM
	HDMI CABLE SLOT

NOTE: ALL FLOOR MOUNTED SOCKETS TO BE FIRED TEMPORARILY. SO THAT IT COULD BE MOVED TO BE FIRED PERMANENTLY. ONCE THE FURNITURE HAVE BEEN PROCURED. - ALL SOCKETS SHOULD BE UNIVERSAL.

NETWORK & SOCKET LAYOUT

REMARKS:

CLIENT:  
SECRETARY OF  
DHDHDDDD COUNCIL


PROJECT:  
COUNCIL OFFICE  
EXTENSION  
H.A. DHDHDDDD

DESIGNERS:  
RANJIB  
ARCHITECTURAL CHECKER  
STRUCTURAL ENGINEER & CHECKER

SCALE : AS GIVEN  
DWG TITLE : AS GIVEN  
DWG NO. : 23

**D H I V E S H I**  
**CONSULTANCY & CONSTRUCTION**

Project Management,  
Building Post Planning,  
Construction &  
Consultancy

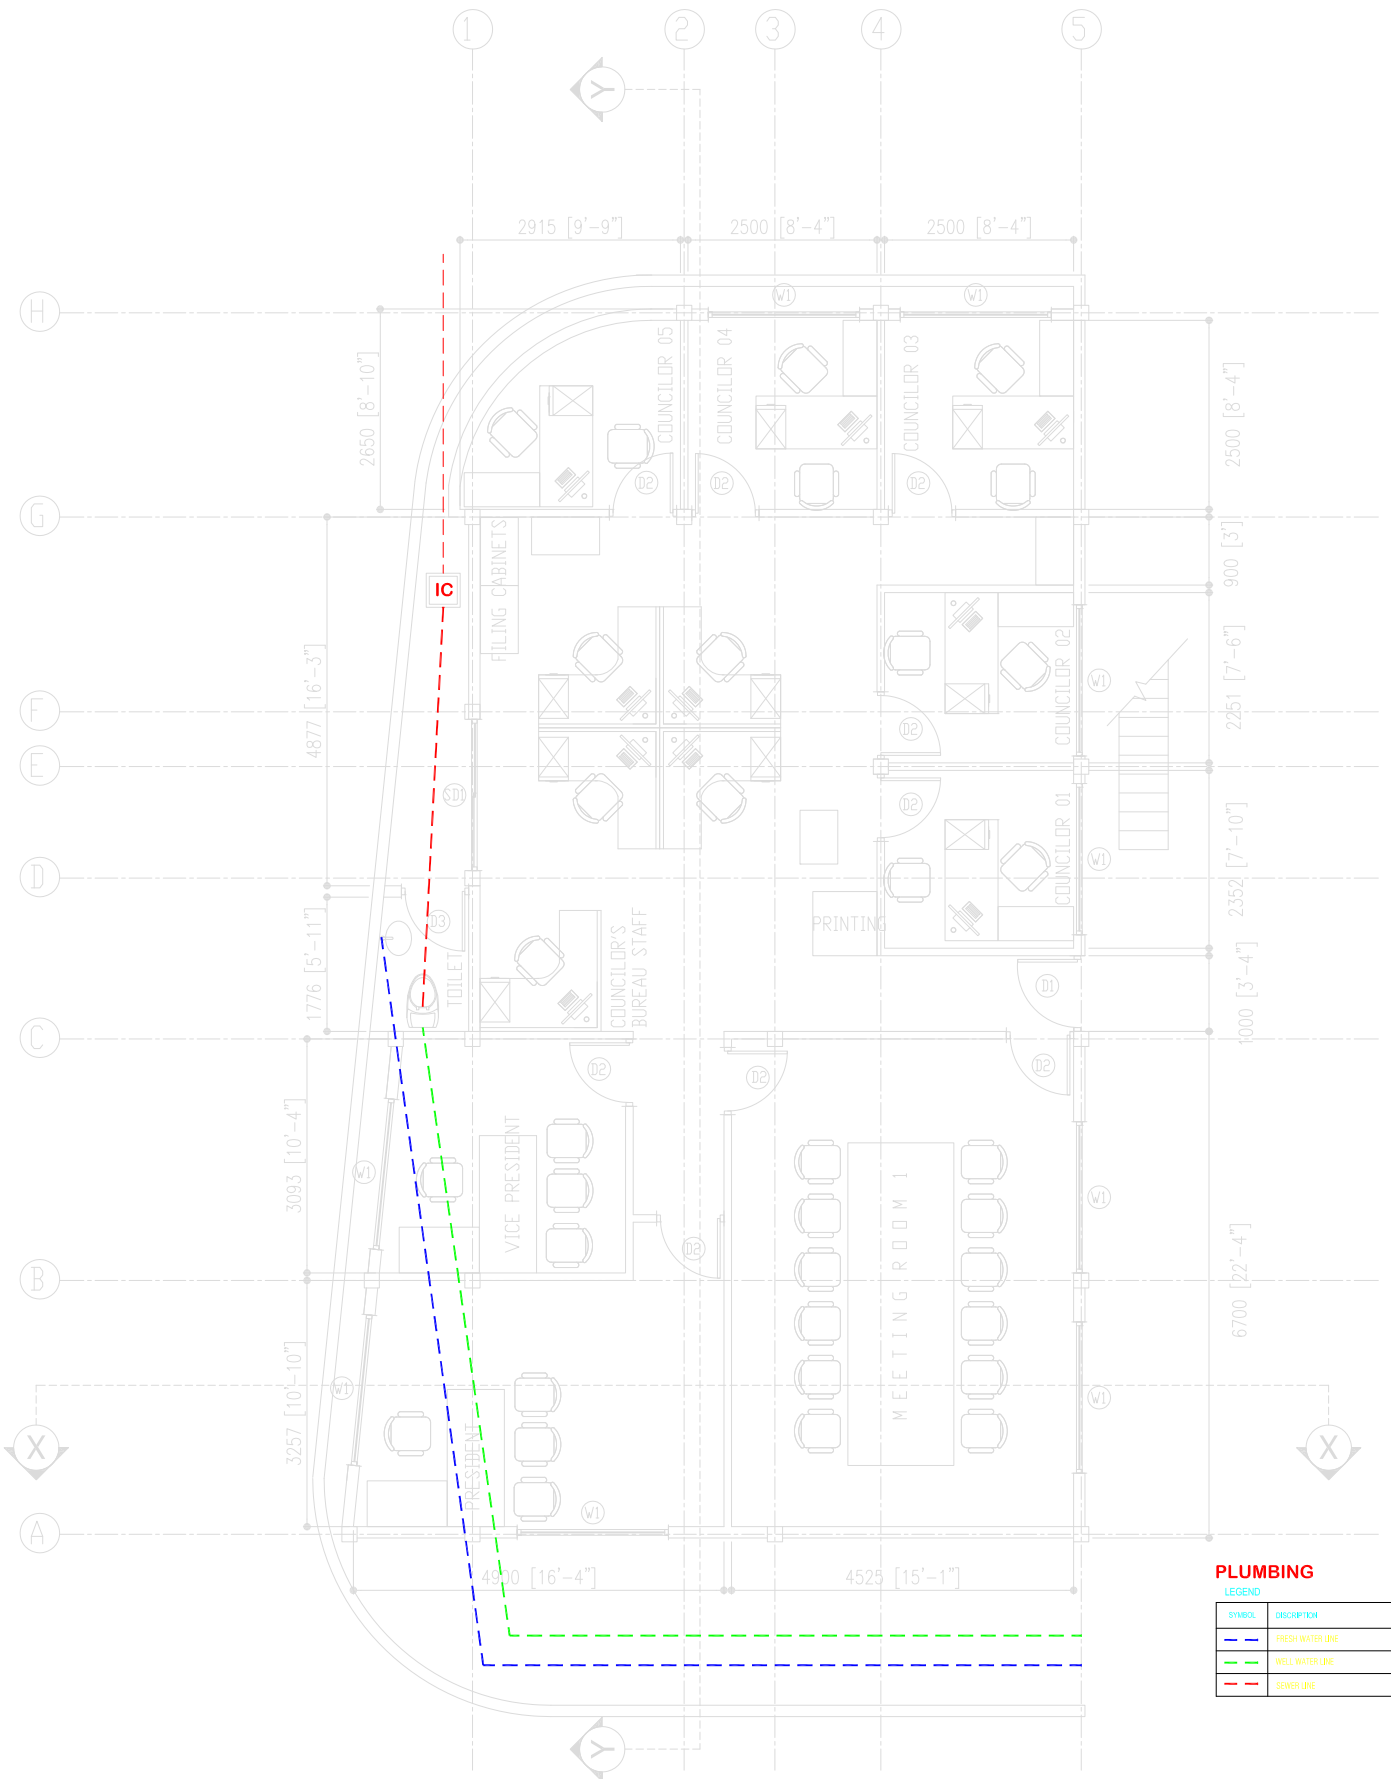

**PLUMBING**  
LEGEND

SYMBOL	DESCRIPTION
	FRESH WATER LINE
	WELL WATER LINE
	SEWER LINE

## PLUMBING LAYOUT

SCALE 1:100

REMARKS:

CLIENT:

SECRETARY OF

DHHDHDD COUNCIL

PROJECT:

COUNCIL OFFICE

EXTENSION

HA DHHDHDD

DESIGNERS:

MANER

ARCHITECTURAL CHECKER

STRUCTURAL ENGINEER & CHECKER

SCALE : AS GIVEN

DWG TITLE : AS GIVEN

DWG NO. : 24



Project Management,  
Building Cost Estimating,  
Construction Supervision &  
Consultancy

D H I V E S H I  
CONSTRUCTION &  
CONSULTANCY