

**CONSULTANCY FOR ARCHITECTURAL FIRM FOR THE DESIGNING  
AND PREPARATION OF DETAILED DRAWINGS, BOQS AND THE  
SUPERVISION OF THE REFURBISHMENTS OF POLYTECHNICS  
MALDIVES POLYTECHNIC, GA.VILLINGILI CAMPUS  
ARCHITECTURAL, STRUCTURAL & SERVICES DRAWINGS**


**SEPTEMBER 2021**

CONTRACT NO: MEERY/2021/GS-016


CLIENT : MINISTRY OF HIGHER EDUCATION

DESIGN BY

 **ArchEng**  
studios  
Ma Fiyajhaage, 1st floor, Male, Republic of Maldives  
admin@archeng.biz



MALDIVES POLYTECHNIC  
GA.VILLINGILI CAMPUS

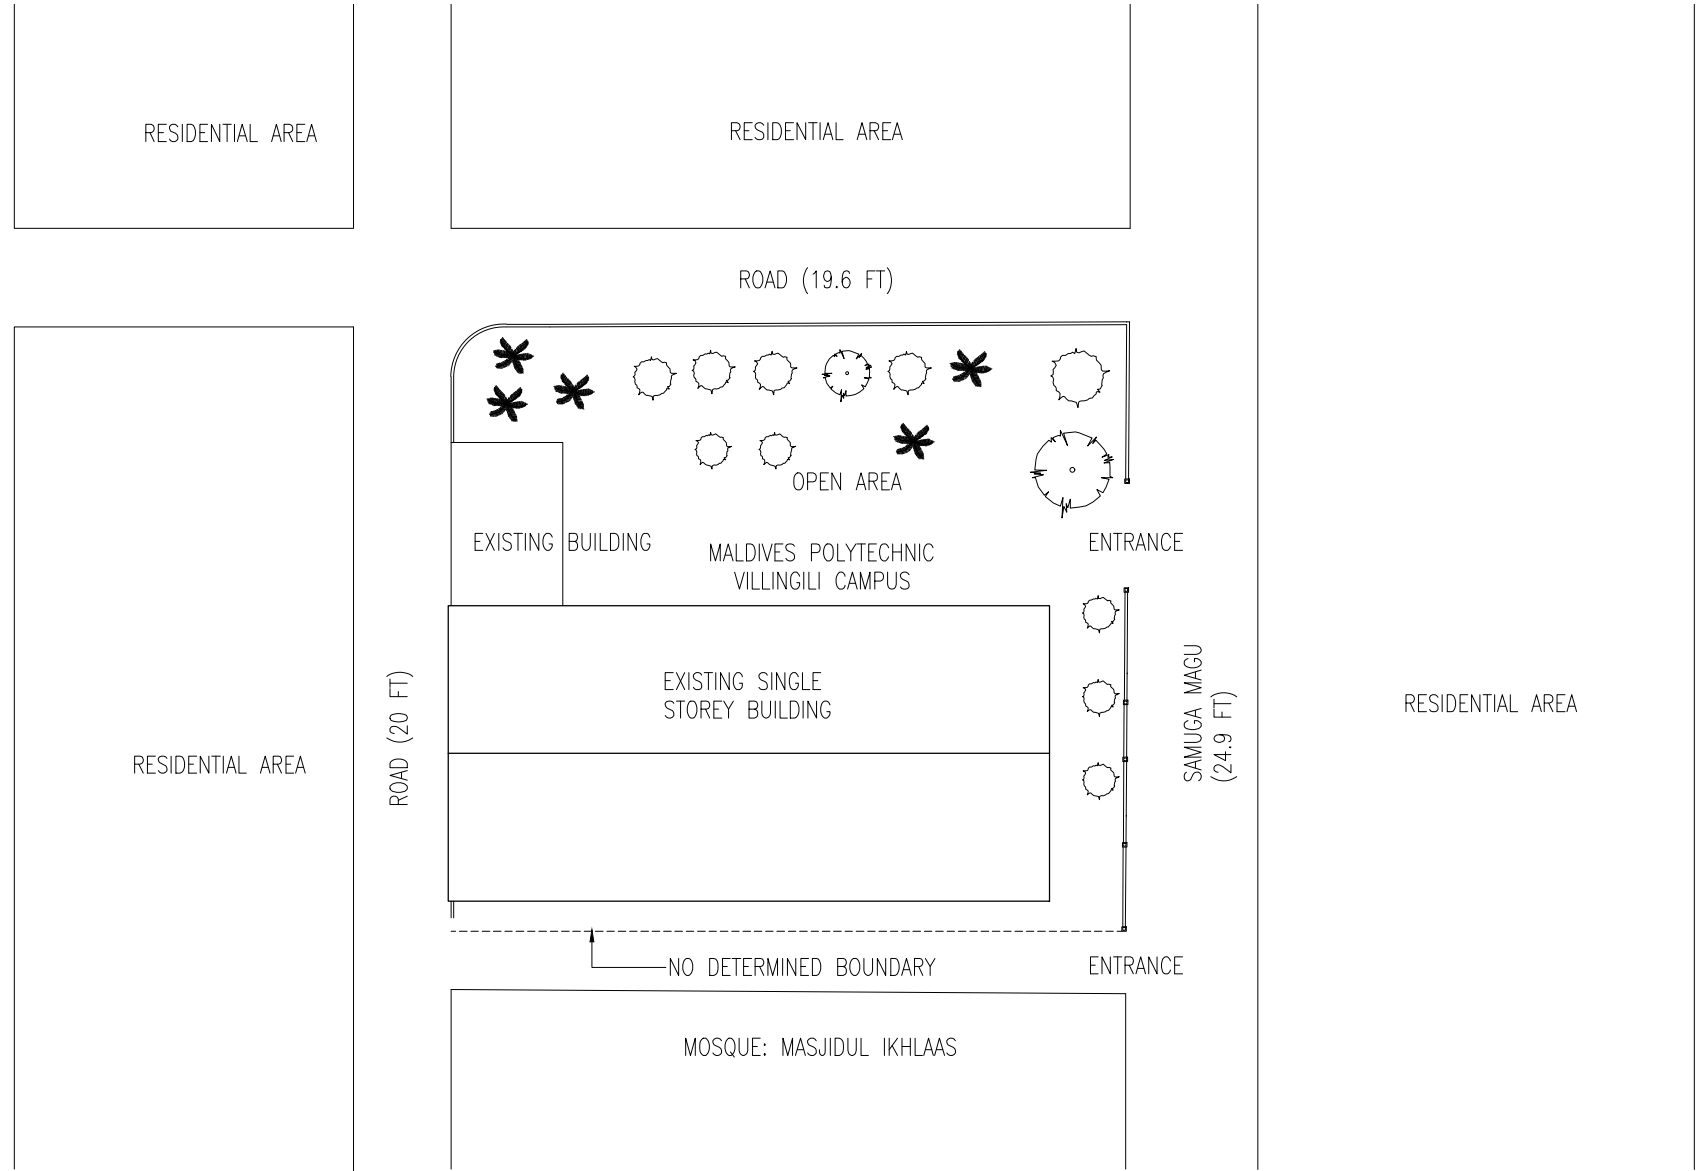

SOURCE: GA. VILLINGILI  
LANDUSE PLAN, MINISTRY  
OF NATIONAL PLANNING  
AND INFRASTRUCTURE

**GA.VILLINGILI ISLAND MAP**  
N.T.S

**LOCATION PLAN**  
N.T.S

CONTRACTORS MUST  
CHECK ALL  
DIMENSIONS ON SITE  
BEFORE STARTING  
ANY WORK OR SHOP  
DRAWINGS, FIGURED  
DIMENSIONS TO TAKE  
PRECEDENCE OVER  
SCALE READINGS





REVISION:	ARCHITECT:	PROJECT:	MALDIVES POLYTECHNIC, GA.VILLINGILI CAMPUS
	ENGINEER:	LOCATION:	GA.VILLINGILI
	ARCHITECTURAL CHECKER:	DRAWING TITLE:	AS GIVEN
	STRUCTURAL CHECKER:	CLIENT:	MINISTRY OF HIGHER EDUCATION
	DRAWN BY:	SCALE:	AS GIVEN
		DIMENSION:	MM
		DATE:	SEPTEMBER 2021
		PROJECT NO:	21-001

**A-01**


DWG NO

CONCEPT AND DESIGN IN THIS DRAWING ARE THE PROPERTIES OF ARCHENG STUDIO PVT LTD. UNAUTHORIZED USE OR REPRODUCTION OF PART OF THE DESIGN, DRAWINGS OR CONCEPT TO USE IN OTHER PROJECTS OR SITES OTHER THAN SPECIFIED ON THIS DRAWING IS PROHIBITED

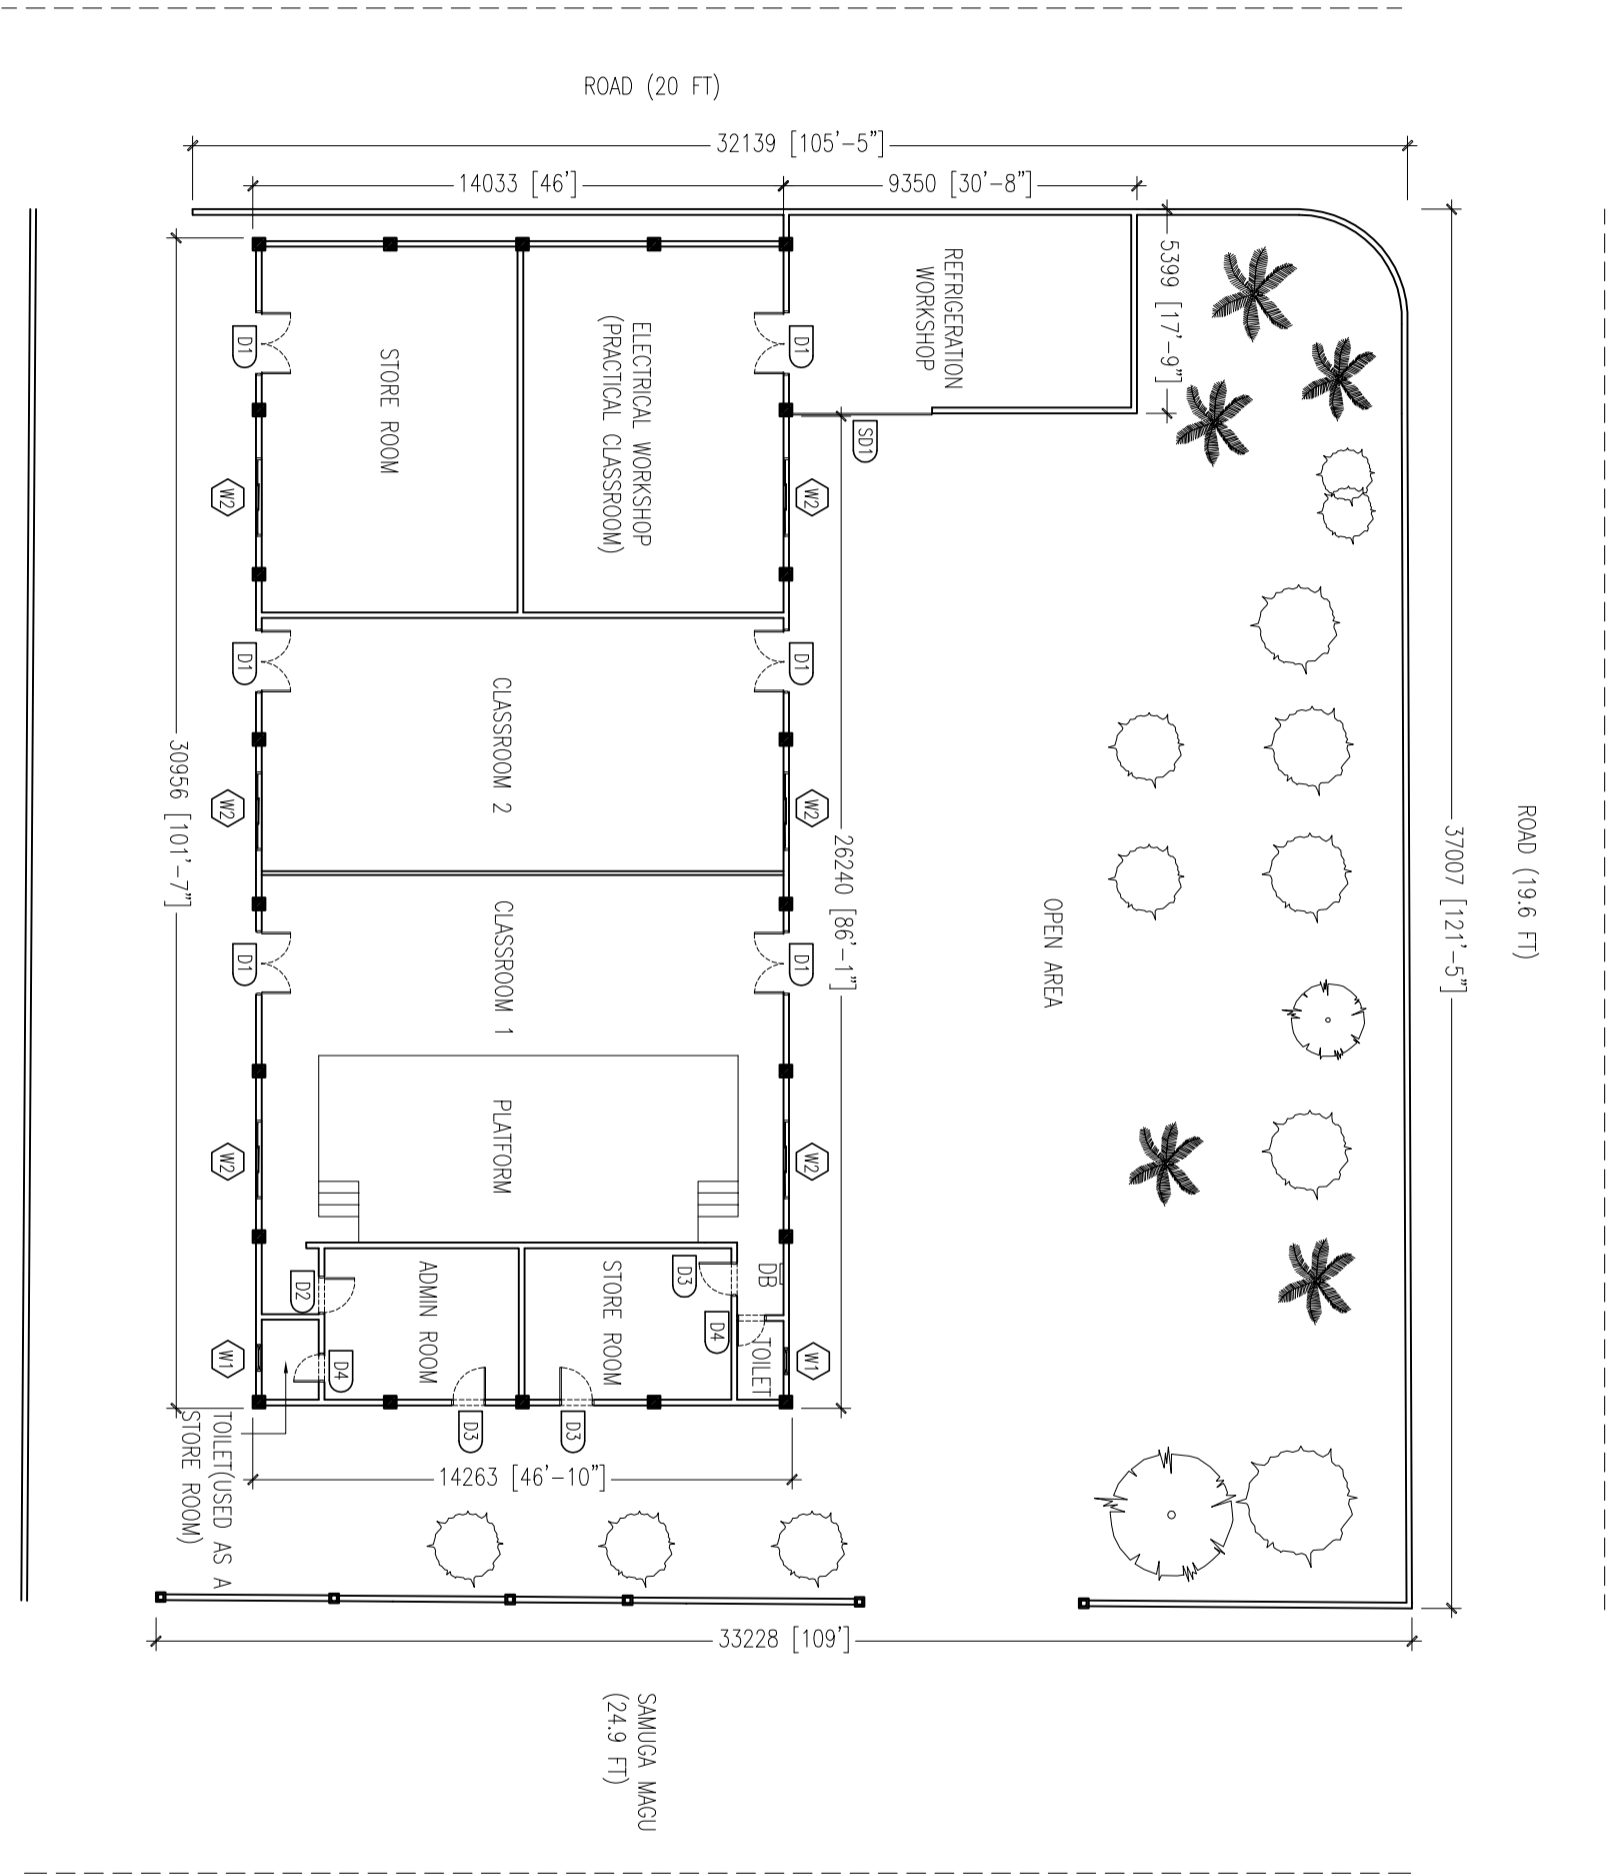 



**GROUND FLOOR PLAN - EXISTING PLAN**  
SCALE 1:200

CONTRACTORS MUST CHECK ALL DIMENSIONS ON SITE BEFORE STARTING ANY WORK OR SHOP DRAWINGS. FIGURED DIMENSIONS TO TAKE PRECEDENCE OVER SCALE READINGS

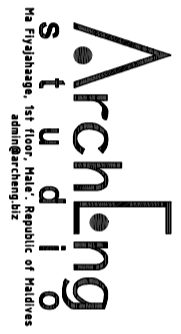

REVISION:	ARCHITECT:	PROJECT:	MALDIVES POLYTECHNIC, GA.VILLINGILI CAMPUS
	ENGINEER:	LOCATION:	GA.VILLINGILI
	ARCHITECTURAL CHECKER:	DRAWING TITLE:	AS GIVEN
	STRUCTURAL CHECKER:	CLIENT:	MINISTRY OF HIGHER EDUCATION
	DRAWN BY:	SCALE:	AS GIVEN
		DIMENSION:	MM
		DATE:	SEPTEMBER 2021
		PROJECT NO.:	21-001
		DWG NO.:	<b>A-02</b>

CONCEPT AND DESIGN IN THIS DRAWING ARE THE PROPERTIES OF ARCHENG STUDIO PVT.LTD. UNAUTHORIZED USE OR REPRODUCTION OF PART OF THE DESIGN DRAWINGS OR CONCEPT TO USE IN OTHER PROJECTS OR SITES OTHER THAN SPECIFIED ON THIS DRAWING IS PROHIBITED

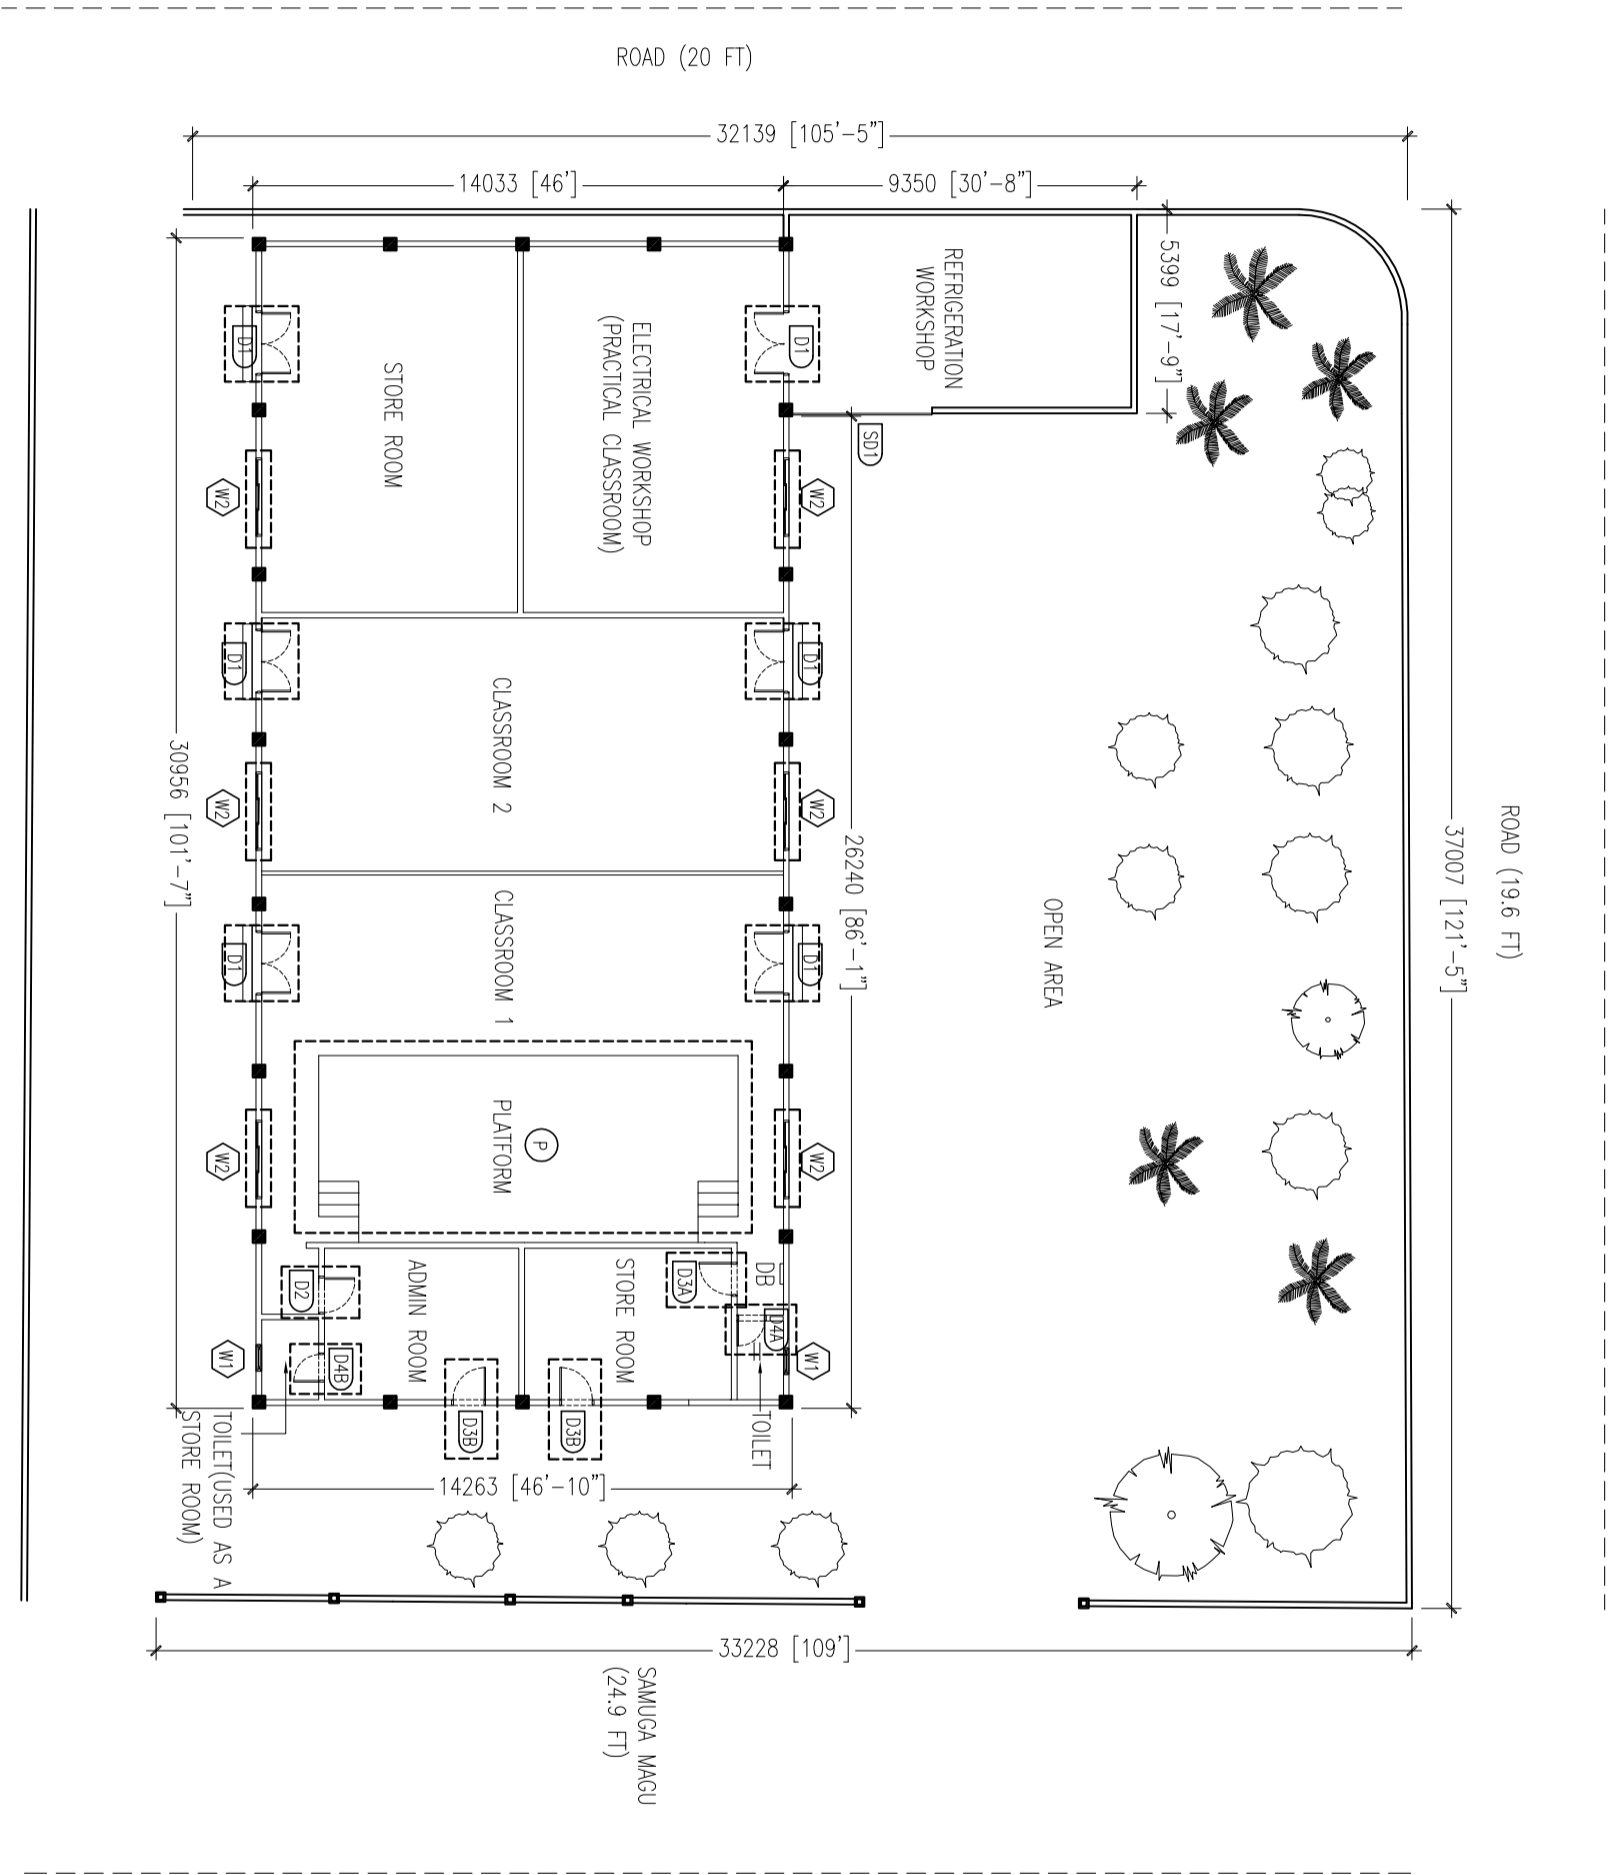 

- LEGEND
- (P) PLATFORM TO BE DEMOLISHED
  - (D1) DOOR-1 TO BE REPLACED WITH NEW DOOR
  - (D2) DOOR-2 TO BE REPLACED WITH NEW DOOR
  - (D3A) DOOR-3A TO BE REMOVED
  - (D3B) DOOR-3B TO BE REPLACED WITH NEW DOOR
  - (D4B) DOOR-4B TO BE REPLACED WITH NEW DOOR
  - (W2) WINDOW-2 TO BE REPLACED WITH NEW WINDOW



**GROUND FLOOR PLAN - DEMOLITION PLAN**  
SCALE 1:200

CONTRACTORS MUST CHECK ALL DIMENSIONS ON SITE BEFORE STARTING ANY WORK OR SHOP DRAWINGS. FIGURED DIMENSIONS TO TAKE PRECEDENCE OVER SCALE READINGS



REVISION:	ARCHITECT:	PROJECT:	MALDIVES POLYTECHNIC, GA.VILILINGILU CAMPUS
	ENGINEER:	LOCATION:	GA.VILILINGILU
	ARCHITECTURAL CHECKER:	DRAWING TITLE:	AS GIVEN
	STRUCTURAL CHECKER:	CLIENT:	MINISTRY OF HIGHER EDUCATION
	DRAWN BY:	SCALE:	AS GIVEN
		DIMENSION:	MM
		DATE:	SEPTEMBER 2021
		PROJECT NO.:	21-001
		DWG NO.:	<b>A-03</b>

CONCEPT AND DESIGN IN THIS DRAWING ARE THE PROPERTIES OF ARCHENG STUDIO PVT.LTD. UNAUTHORIZED USE OR REPRODUCTION OF PART OF THE DESIGN DRAWINGS OR SITES OTHER THAN SPECIFIED ON THIS DRAWING IS PROHIBITED

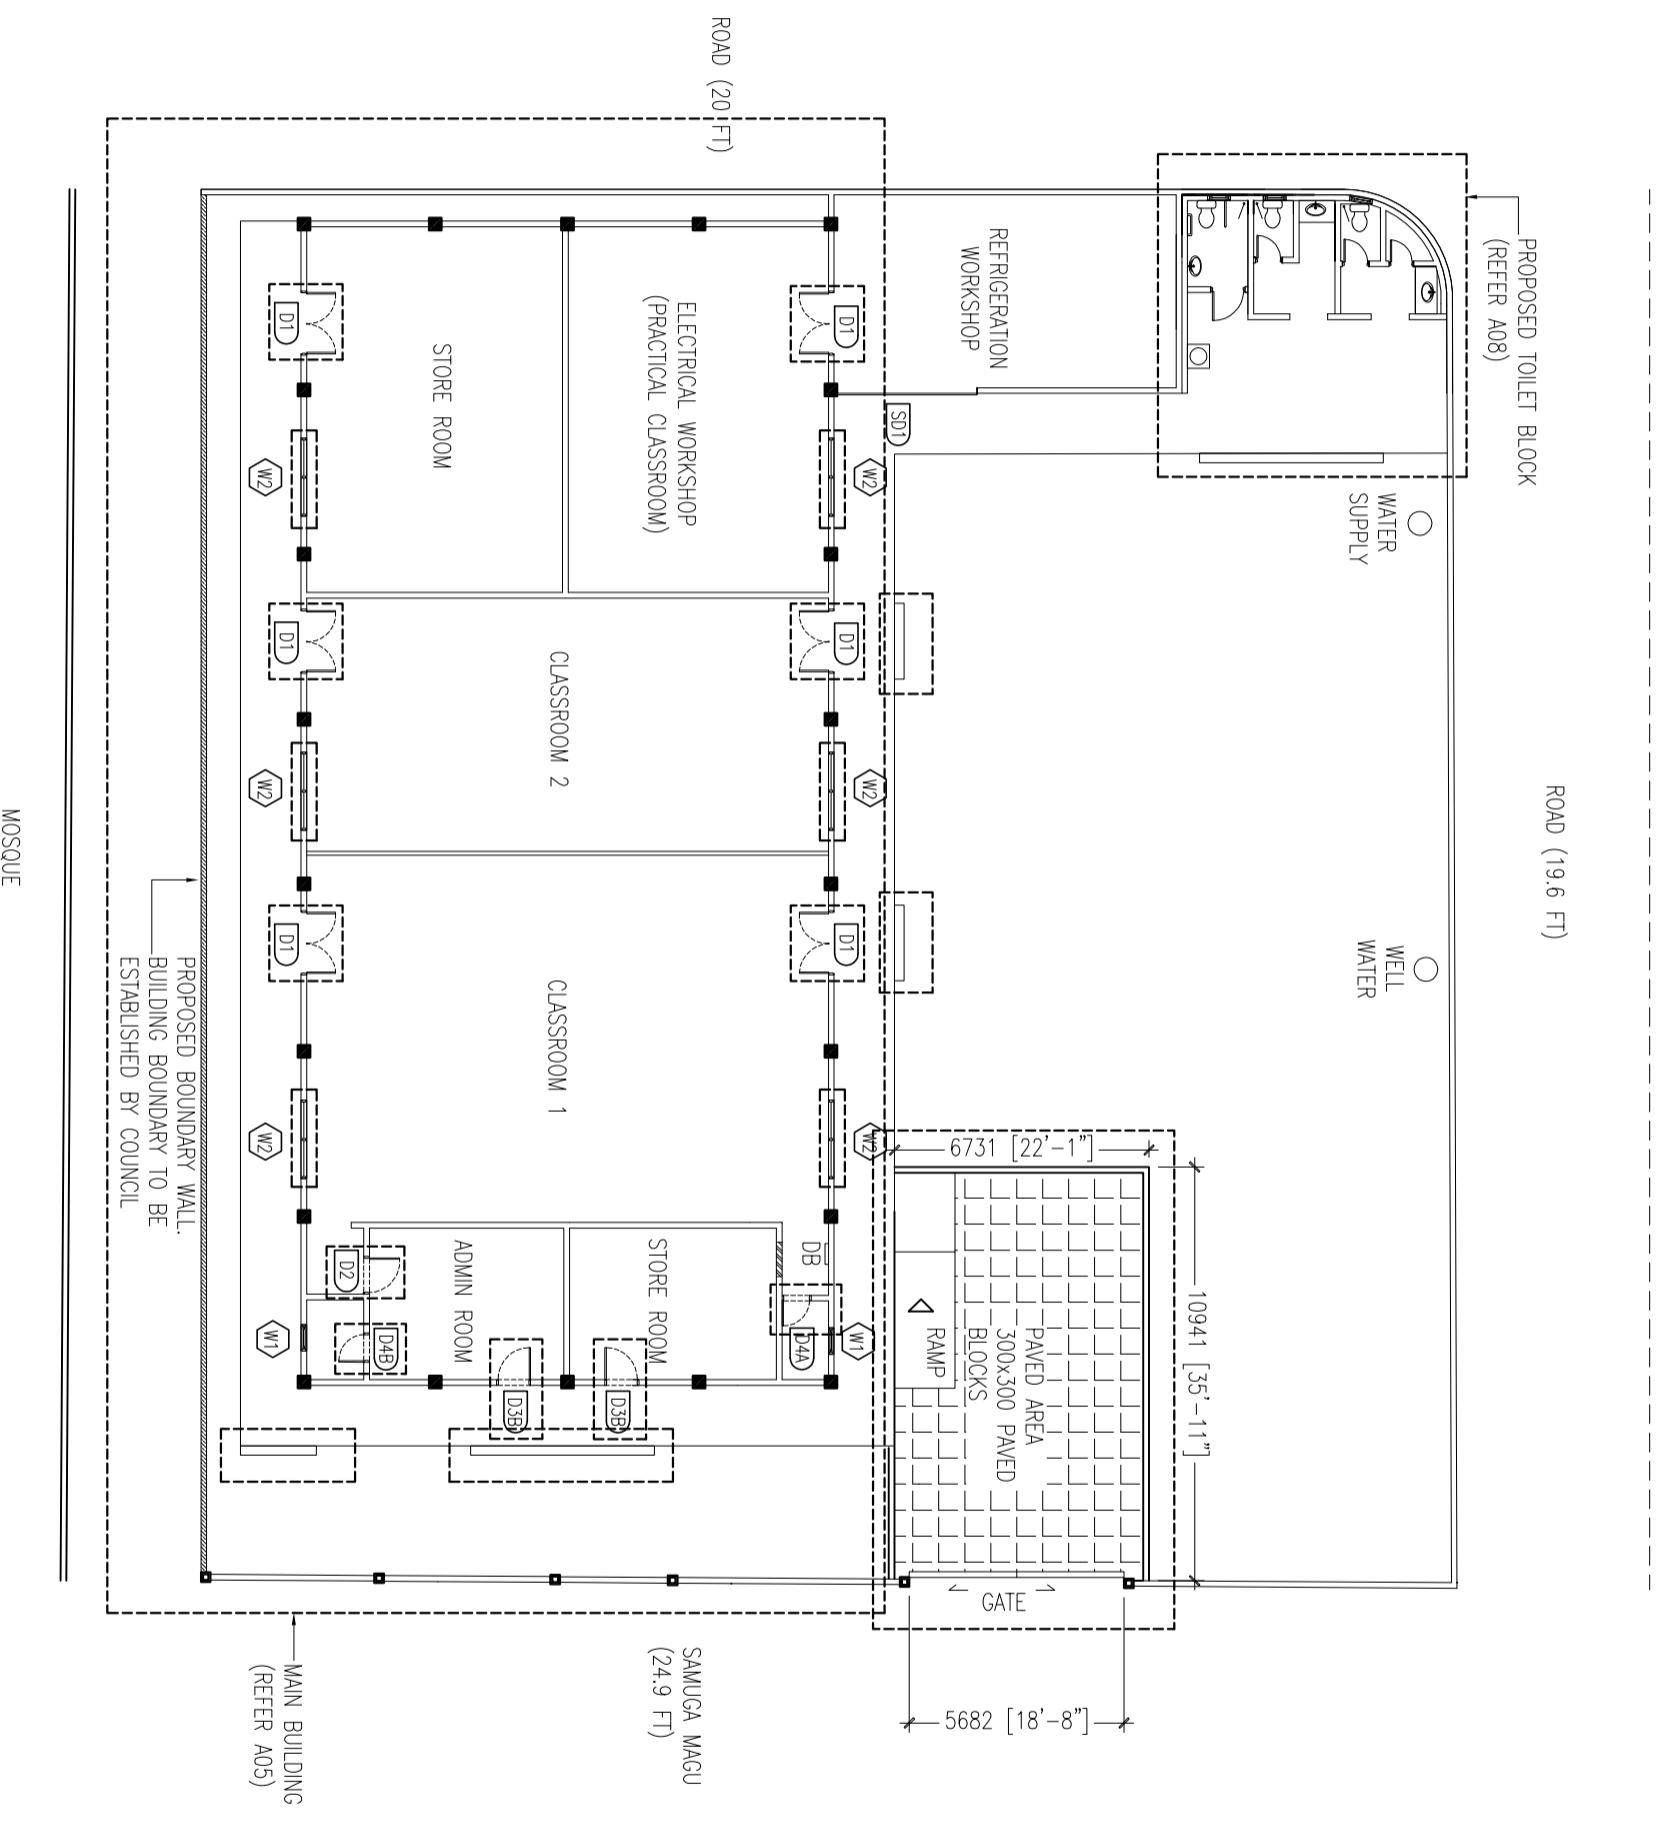 

### GROUND FLOOR PLAN - PROPOSED KEY PLAN


SCALE 1:200

CONTRACTORS MUST CHECK ALL DIMENSIONS ON SITE BEFORE STARTING ANY WORK OR SHOP DRAWINGS. FIGURED DIMENSIONS TO TAKE PRECEDENCE OVER SCALE READINGS



REVISION:	ARCHITECT:	PROJECT:	MALDIVES POLYTECHNIC, GAVILINGILU CAMPUS
	ENGINEER:	LOCATION:	GAVILINGILU
	ARCHITECTURAL CHECKER:	DRAWING TITLE:	AS GIVEN
	STRUCTURAL CHECKER:	CLIENT:	MINISTRY OF HIGHER EDUCATION
	DRAWN BY:	SCALE:	AS GIVEN
		DRAWING NO:	MM
		DATE:	SEPTEMBER 2021
		PROJECT NO:	21-001
		DWG NO:	<b>A-04</b>

CONCEPT AND DESIGN IN THIS DRAWING ARE THE PROPERTIES OF ARCHENG STUDIO PVT LTD. UNAUTHORIZED USE OR REPRODUCTION OF PART OF THE DESIGN DRAWINGS OR CONCEPT TO USE IN OTHER PROJECTS OR SITES OTHER THAN SPECIFIED ON THIS DRAWING IS PROHIBITED

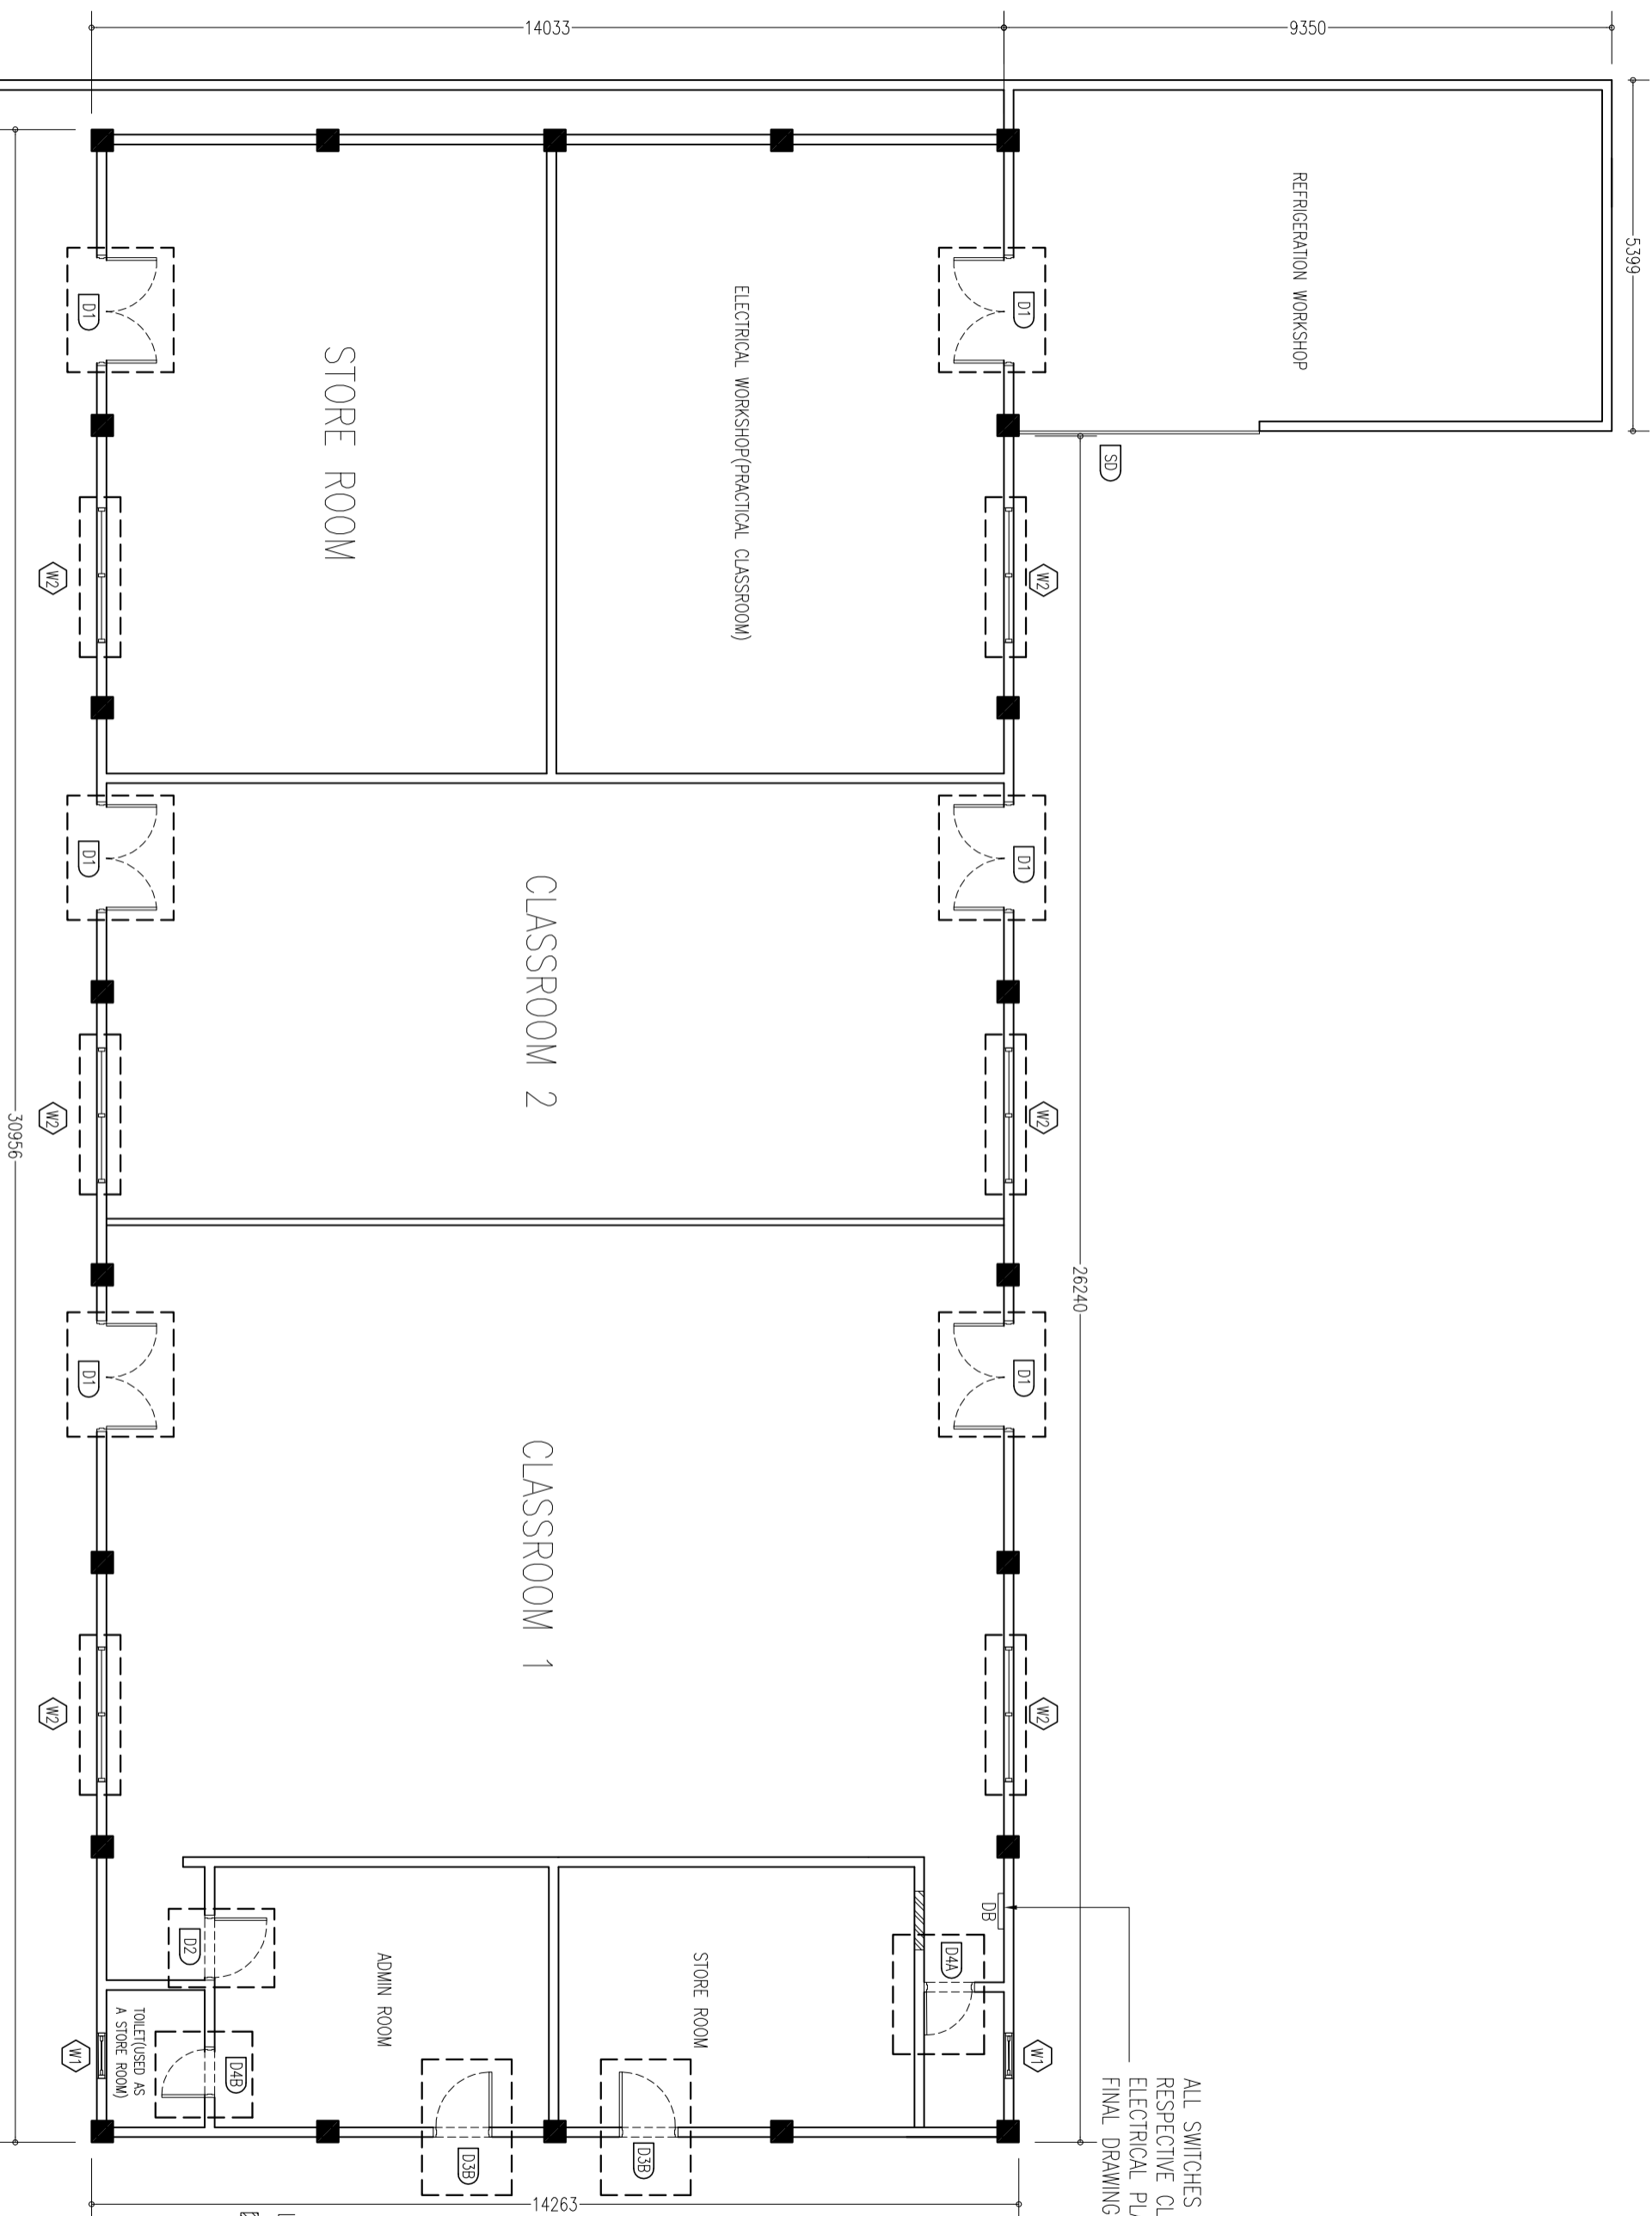

ALL SWITCHES TO BE RELOCATED TO THE RESPECTIVE CLASSROOMS. NEW ELECTRICAL PLANS TO BE PROPOSED WITH FINAL DRAWINGS

- LEGEND
- WALL TO BE CONSTRUCTED
  - NEWLY ATTACHED DOOR
  - NEWLY ATTACHED DOOR
  - NEWLY ATTACHED DOOR
  - NEWLY ATTACHED DOOR
  - NEWLY ATTACHED WINDOW

### GROUND FLOOR - MAIN BUILDING








SCALE 1:100

CONTRACTORS MUST CHECK ALL DIMENSIONS ON SITE BEFORE STARTING ANY WORK OR SHOP DIMENSIONS TO TAKE PRECEDENCE OVER SCALE REMAININGS



REVISION:	ARCHITECT:	PROJECT:	MALDIVES POLYTECHNIC, GAVILINGILU CAMPUS	DWG NO	<b>A-05</b>
	ENGINEER: MARIYAM SAMAH	LOCATION:	GAVILINGILU	PROJECT NO:	21-001
	ARCHITECTURAL CHECKER:	DRAWING TITLE:	AS GIVEN		
	STRUCTURAL CHECKER: HAMWA NISWA	CLIENT:	MINISTRY OF HIGHER EDUCATION		
	DRAWN BY:	SCALE:	AS GIVEN	DIMENSION:	MM
		DATE:	SEPTEMBER 2021		

CONCEPT AND DESIGN IN THIS DRAWING ARE THE PROPERTIES OF ARCHENG STUDIO PVT LTD. UNAUTHORIZED USE OR REPRODUCTION OF PART OF THE DESIGN DRAWINGS OR CONCEPT TO USE IN OTHER PROJECTS OR SITES OTHER THAN SPECIFIED ON THIS DRAWING IS PROHIBITED
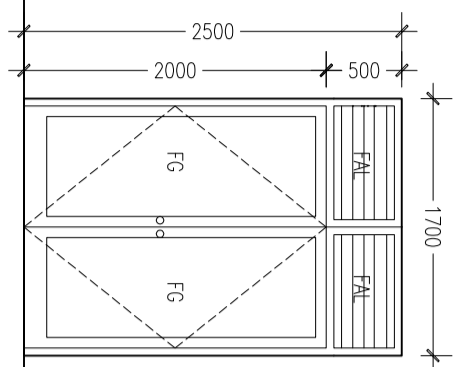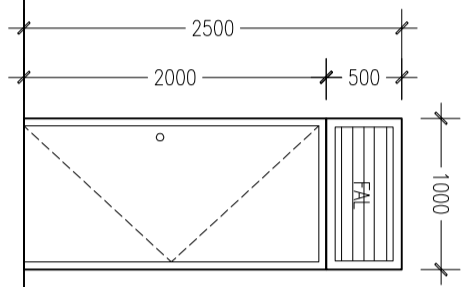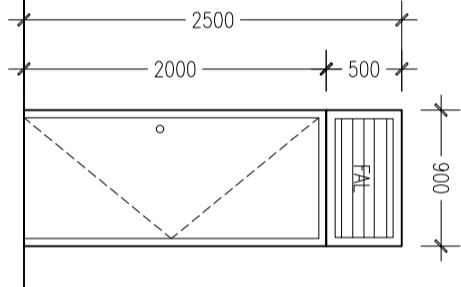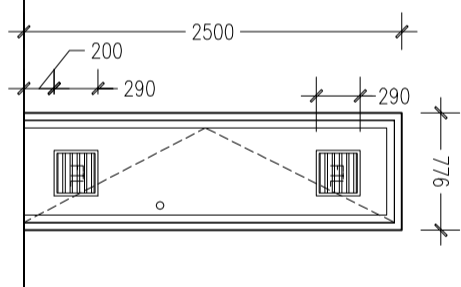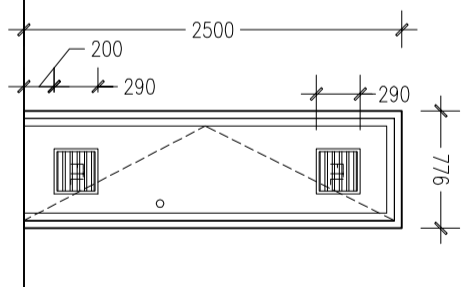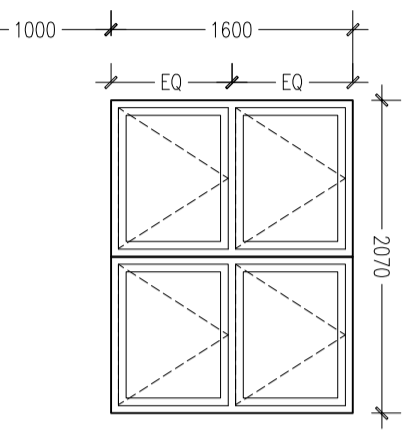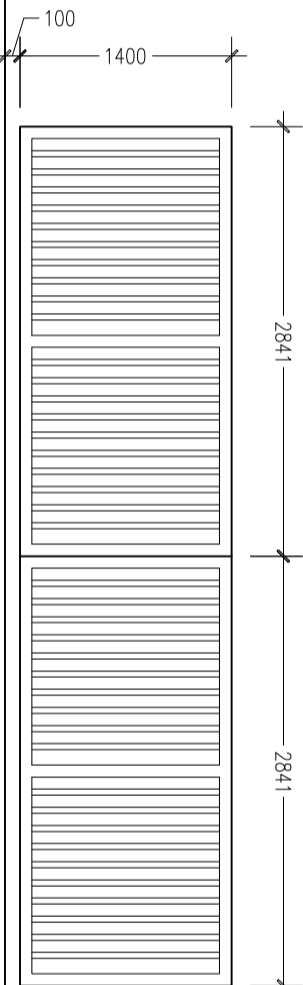
<p>ELEVATIONS :</p> <p>FINISH FLOOR LEVEL</p>					
<p>DR / WD NO.</p>	<p>D1</p>	<p>D2</p>	<p>D3B</p>	<p>D4A</p>	<p>D4B</p>
<p>DESCRIPTION :</p>	<p>40MM THICK OPENABLE ALUMINIUM DOOR PANEL</p>	<p>40MM THICK OPENABLE ALUMINIUM DOOR PANEL</p>	<p>40MM THICK OPENABLE ALUMINIUM DOOR PANEL</p>	<p>40MM THICK OPENABLE ALUMINIUM DOOR PANEL</p>	<p>40MM THICK OPENABLE ALUMINIUM DOOR PANEL</p>
<p>FRAME :</p>	<p>40 MICRON WHITE POWDER COATED ALUMINIUM FRAME</p>	<p>40 MICRON WHITE POWDER COATED ALUMINIUM FRAME</p>	<p>40 MICRON WHITE POWDER COATED ALUMINIUM FRAME</p>	<p>40 MICRON WHITE POWDER COATED ALUMINIUM FRAME</p>	<p>40 MICRON WHITE POWDER COATED ALUMINIUM FRAME</p>
<p>HARDWARE :</p>	<p>DOOR CLOSER CYLINDRICAL LOCK BUTT HINGE STOPPER HOLDER</p>	<p>DOOR CLOSER CYLINDRICAL LOCK BUTT HINGE STOPPER HOLDER</p>	<p>DOOR CLOSER CYLINDRICAL LOCK BUTT HINGE STOPPER HOLDER</p>	<p>DOOR CLOSER CYLINDRICAL LOCK BUTT HINGE STOPPER HOLDER</p>	<p>DOOR CLOSER CYLINDRICAL LOCK BUTT HINGE STOPPER HOLDER</p>
<p>GLAZING :</p>	<p>6MM THICK CLEAR GLASS</p>	<p>C-4MM</p>	<p>C-4MM</p>	<p>C-4MM</p>	<p>C-4MM</p>
<p>ELEVATIONS :</p> <p>FINISH FLOOR LEVEL</p>					
<p>DR / WD NO.</p>	<p>W2</p>				
<p>DESCRIPTION :</p>	<p>ALUMINIUM FRAMED TOP HUNG WINDOW PANELS</p>				
<p>FRAME :</p>	<p>80 MICRON WHITE POWDER COATED ALUMINIUM FRAME</p>				
<p>HARDWARE :</p>	<p>04 NOS. GLAZED TOP HUNG WINDOW PANELS 04 NO. LOCK</p>				
<p>GLAZING :</p>	<p>6MM THICK HEAT REFLECTIVE GLASS</p>				
<p>ENTRANCE GATE</p>					



**PROPOSED DOOR/WINDOW SCHEDULE**  
SCALE 1:50

CONTRACTORS MUST CHECK ALL DIMENSIONS ON SITE BEFORE ANY WORK OR SHOP DRAWINGS FIGURED DIMENSIONS TO TAKE PRECEDENCE OVER SCALE READINGS

**ArchEng**  
s t u d i o  
No 17/A/2018, 1st floor, 'Mala', Republic of Maldives  
archeng@archeng.biz


REVISION:	ARCHITECT:	PROJECT:	MALDIVES POLYTECHNIC, GAVILINGILI CAMPUS
	ENGINEER: MARIYAM SAMA	LOCATION:	GAVILINGILI
	ARCHITECTURAL CHECKER:	DRAWING TITLE:	AS GIVEN
	STRUCTURAL CHECKER:	CLIENT:	MINISTRY OF HIGHER EDUCATION
	DRAWN BY: HANNA NISVA	SCALE:	AS GIVEN
		DIMENSION:	MM
		DATE:	SEPTEMBER 2021
		PROJECT NO.:	21-001
		DWG NO.	<b>A-06</b>

CONCEPT AND DESIGN IN THIS DRAWING ARE THE PROPERTIES OF ARCHENG STUDIO PVT.LTD. UNAUTHORIZED USE OR REPRODUCTION OF PART OF THE DESIGN/DRAWINGS OR CONCEPT TO USE IN OTHER PROJECTS OR SIMILAR OTHER THAN SPECIFIED ON THIS DRAWING IS PROHIBITED

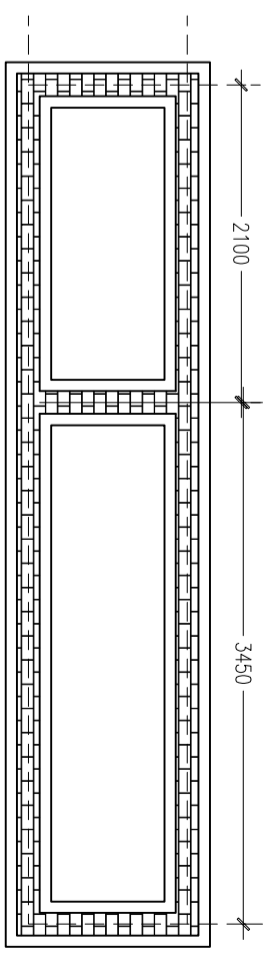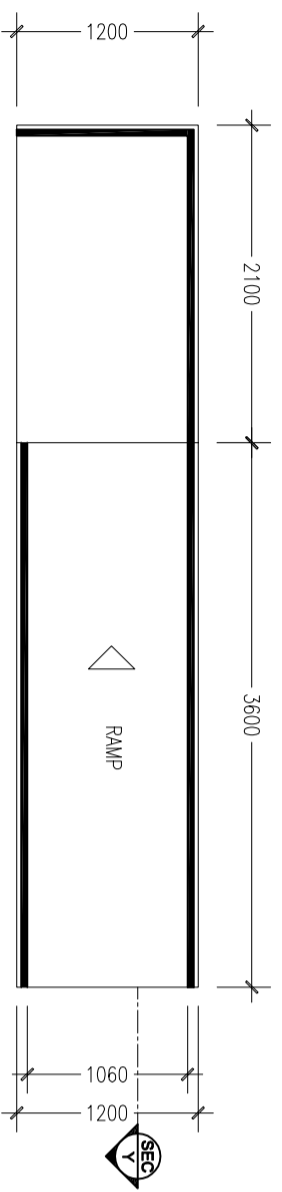


**PROPOSED RAMP**

SCALE 1:50

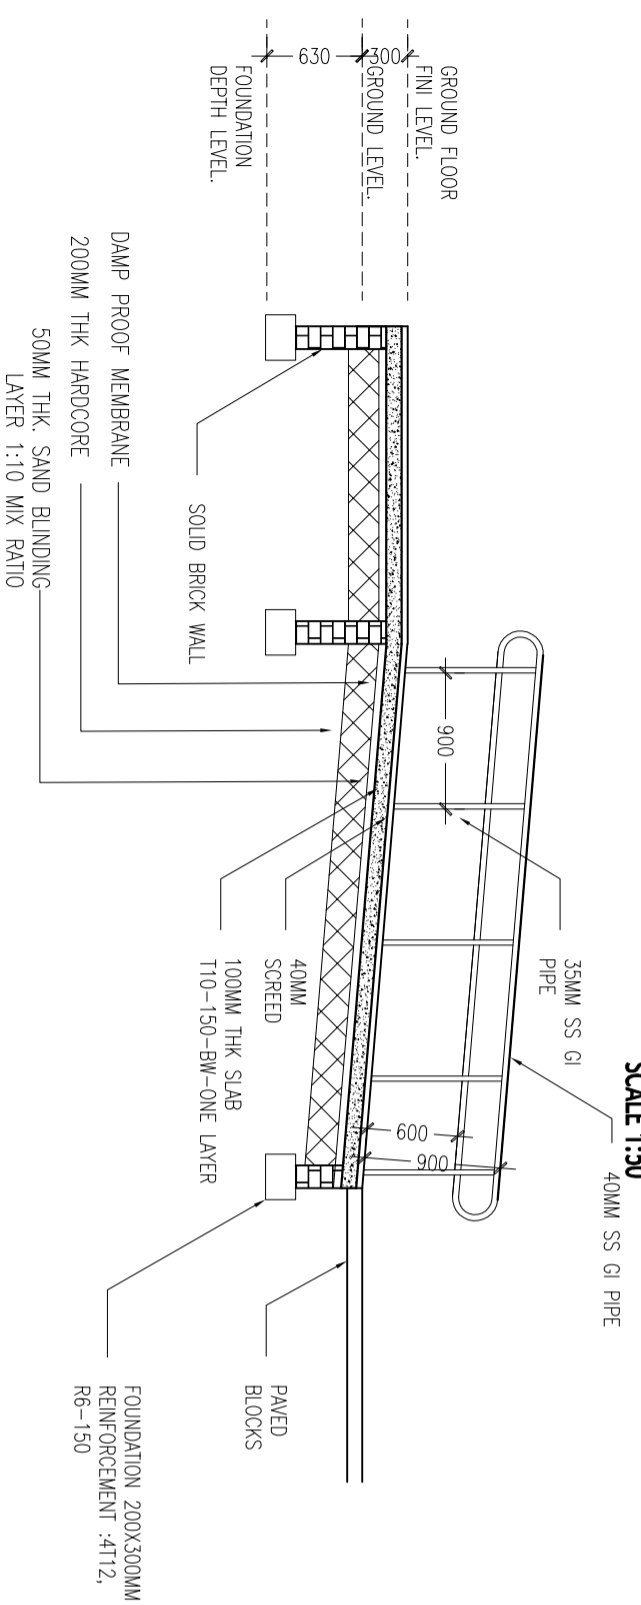

**PROPOSED RAMP DETAIL**

SCALE 1:50

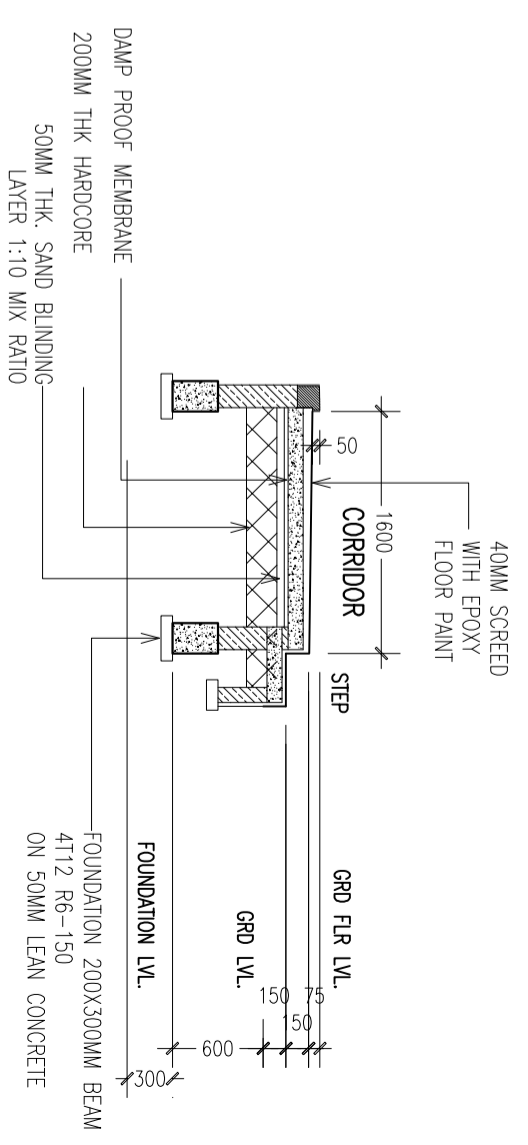


**PROPOSED RAMP - SECTION Y**

SCALE 1:50

**STAIR DETAIL**

SCALE 1:50


CONTRACTORS MUST CHECK ALL DIMENSIONS ON SITE BEFORE ANY WORK OR SHOP DRAWINGS, FIGURED DIMENSIONS TO TAKE PRECEDENCE OVER SCALE READINGS

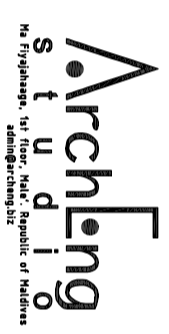

REVISION:	ARCHITECT:	PROJECT:	MALDIVES POLYTECHNIC, GAVILINGILU CAMPUS
	ENGINEER: MARIYAM SUAAH	LOCATION:	GAVILINGILU
	ARCHITECTURAL CHECKER:	DRAWING TITLE:	AS GIVEN
	STRUCTURAL CHECKER:	CLIENT:	MINISTRY OF HIGHER EDUCATION
	DRAWN BY: HAWWA NISWA	SCALE: AS GIVEN	DIMENSION: MM
		DATE: SEPTEMBER 2021	
			PROJECT NO.: 21-001
			DWG NO
			<b>A-07</b>

CONCEPT AND DESIGN IN THIS DRAWING ARE THE PROPERTIES OF ARCHING STUDIO PVT LTD. UNAUTHORIZED USE OR REPRODUCTION OF PART OF THE DESIGN/DRAWINGS OR CONCEPT TO USE IN OTHER PROJECTS OR SITES OTHER THAN SPECIFIED ON THIS DRAWING IS PROHIBITED




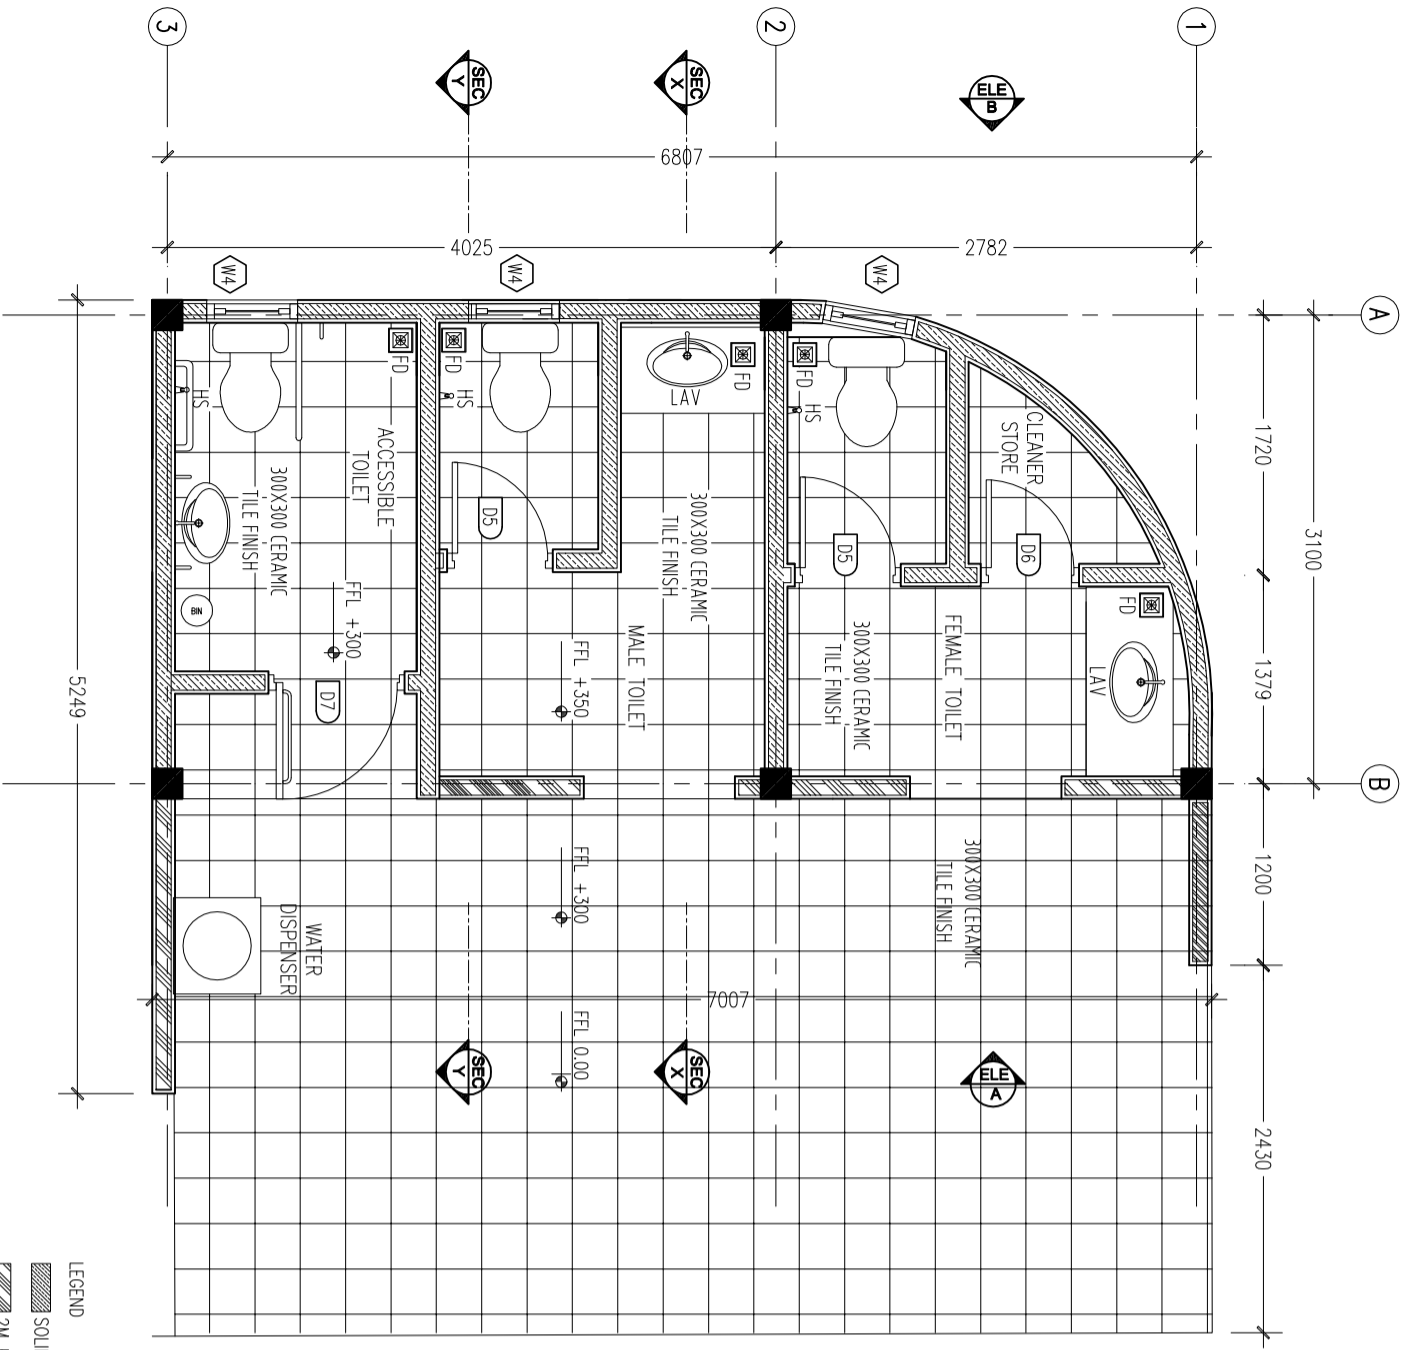


**TOILET BLOCK FLOOR PLAN**  
SCALE 1:50

- LEGEND**
- SOLID BLOCK MASONRY WALL
  - 2M HIGH MASONRY WALL
  - 1.1M HIGH BOUNDARY WALL
  - SOLID BLOCK WALL
  - CONCRETE
  - EARTH
- LEGEND**
- FD : FLOOR DRAIN
  - HS : HAND SHOWER

NOTE :  
ALL TOILETS FLOOR TO BE WATER PROOF  
BY CONMIX MOYA PROOF HF

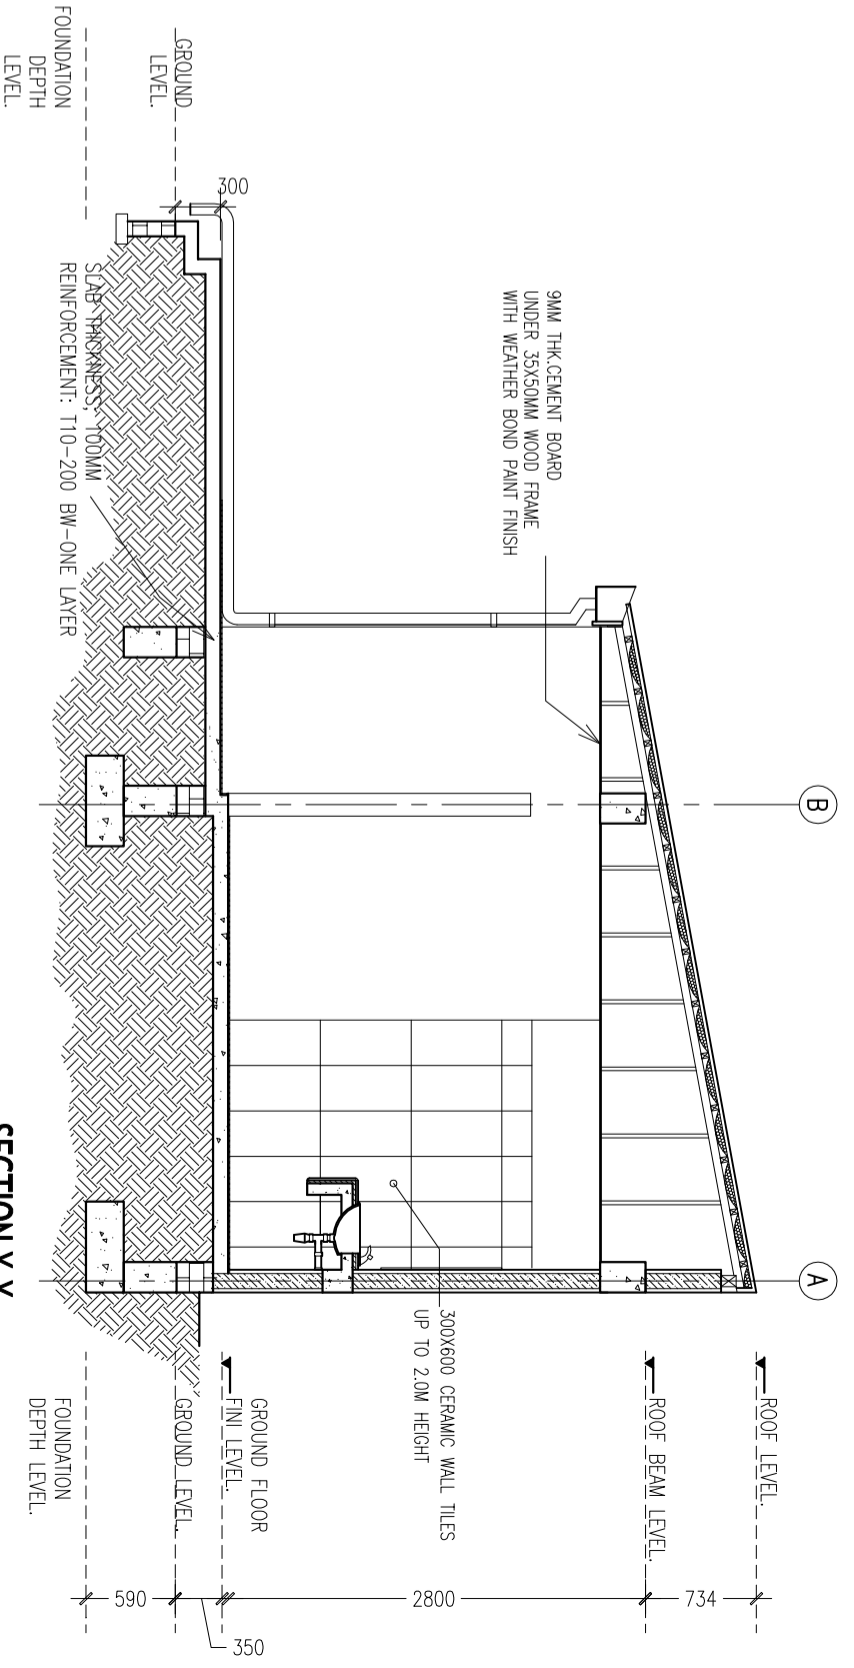


**SECTION X-X**  
SCALE 1:50

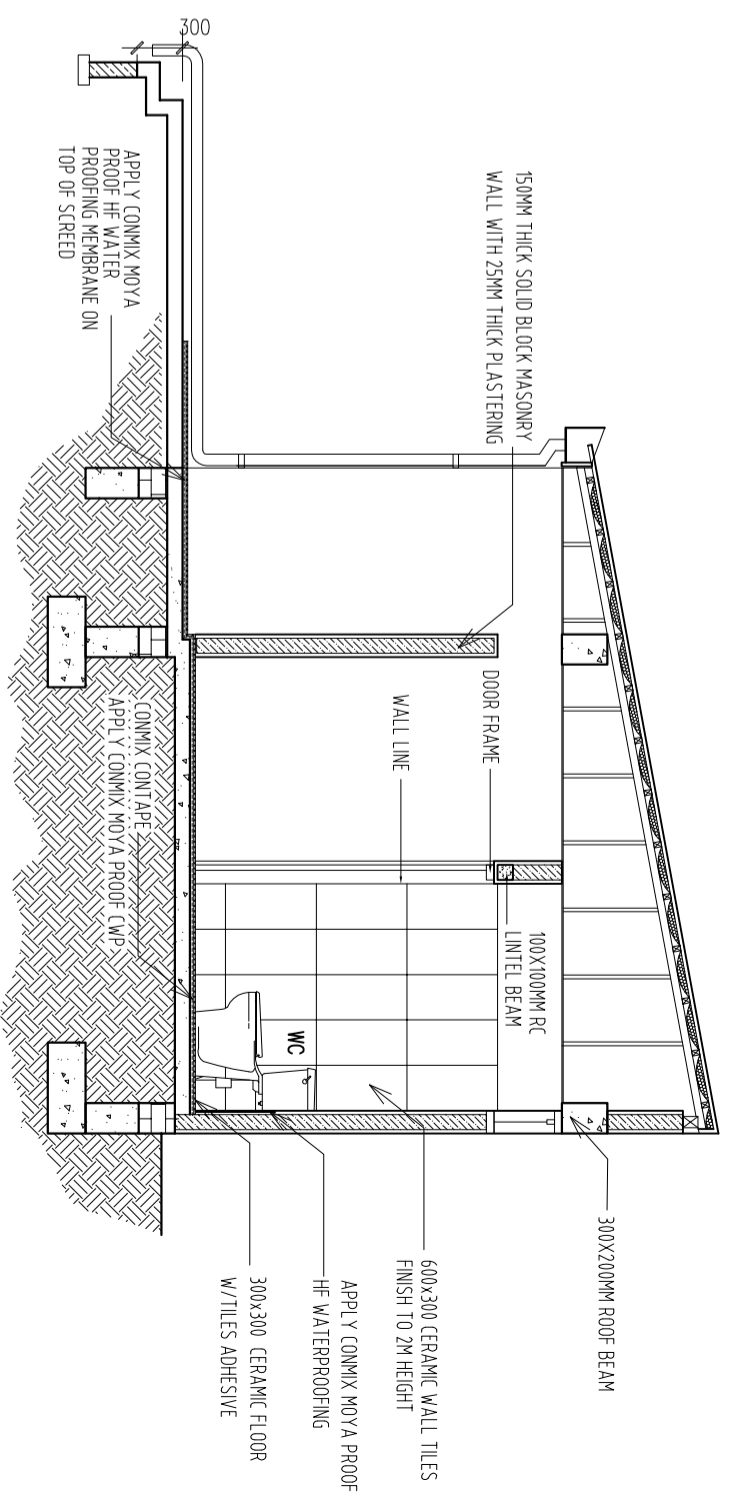


**SECTION Y-Y (TOILET DETAIL)**  
SCALE 1:50

CONTRACTORS MUST CHECK ALL DIMENSIONS ON SITE BEFORE STARTING ANY WORK OR SHOP DRAWINGS. REQUIRED DIMENSIONS TO TAKE SCALE READINGS

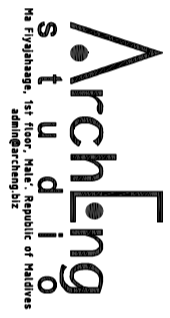


REVISION:	ARCHITECT:	PROJECT:	DATE:
ENGINEER:	MARIYAM SAMAH	MALDIVES POLYTECHNIC, GA.VILINGILU CAMPUS	SEPTEMBER 2021
ARCHITECTURAL CHECKER:		LOCATION:	GA.VILINGILU
STRUCTURAL CHECKER:		DRAWING TITLE:	AS GIVEN
DRAWN BY:	HAWWA NISWA	CLIENT:	MINISTRY OF HIGHER EDUCATION
		SCALE:	AS GIVEN
		DIMENSION:	MM
		PROJECT NO.:	21-001
		DWG NO.	<b>A-08</b>

CONCEPT AND DESIGN IN THIS DRAWING ARE THE PROPERTIES OF ARCHING STUDIO PVT LTD. UNAUTHORIZED USE OR REPRODUCTION OF PART OF THE DESIGN/DRAWINGS OR CONCEPT TO USE IN OTHER PROJECTS OR SITES OTHER THAN SPECIFIED ON THIS DRAWING IS PROHIBITED

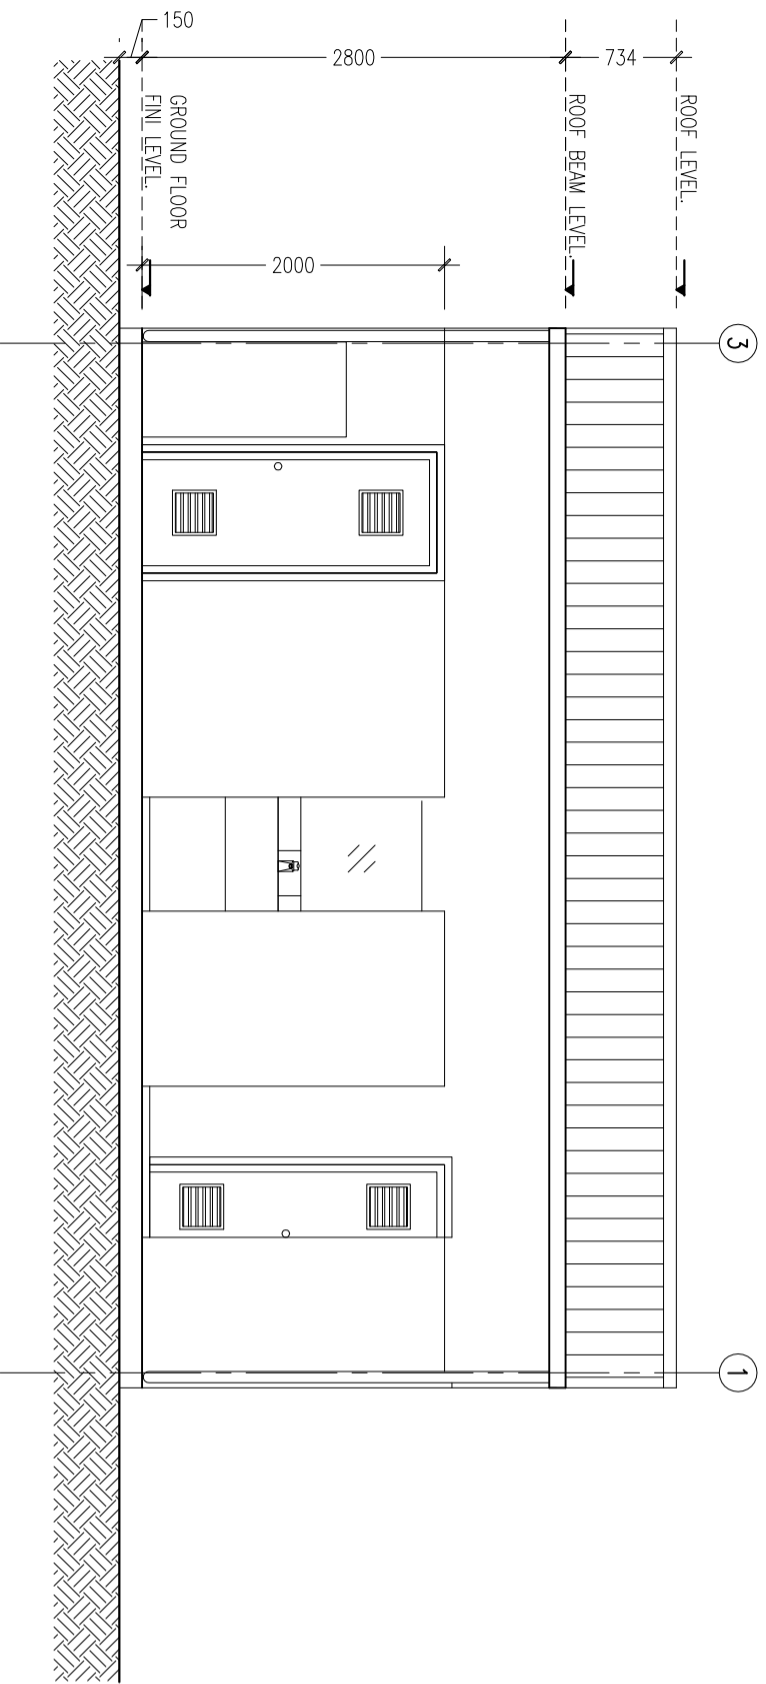


**ELEVATION-A**  
SCALE 1:50

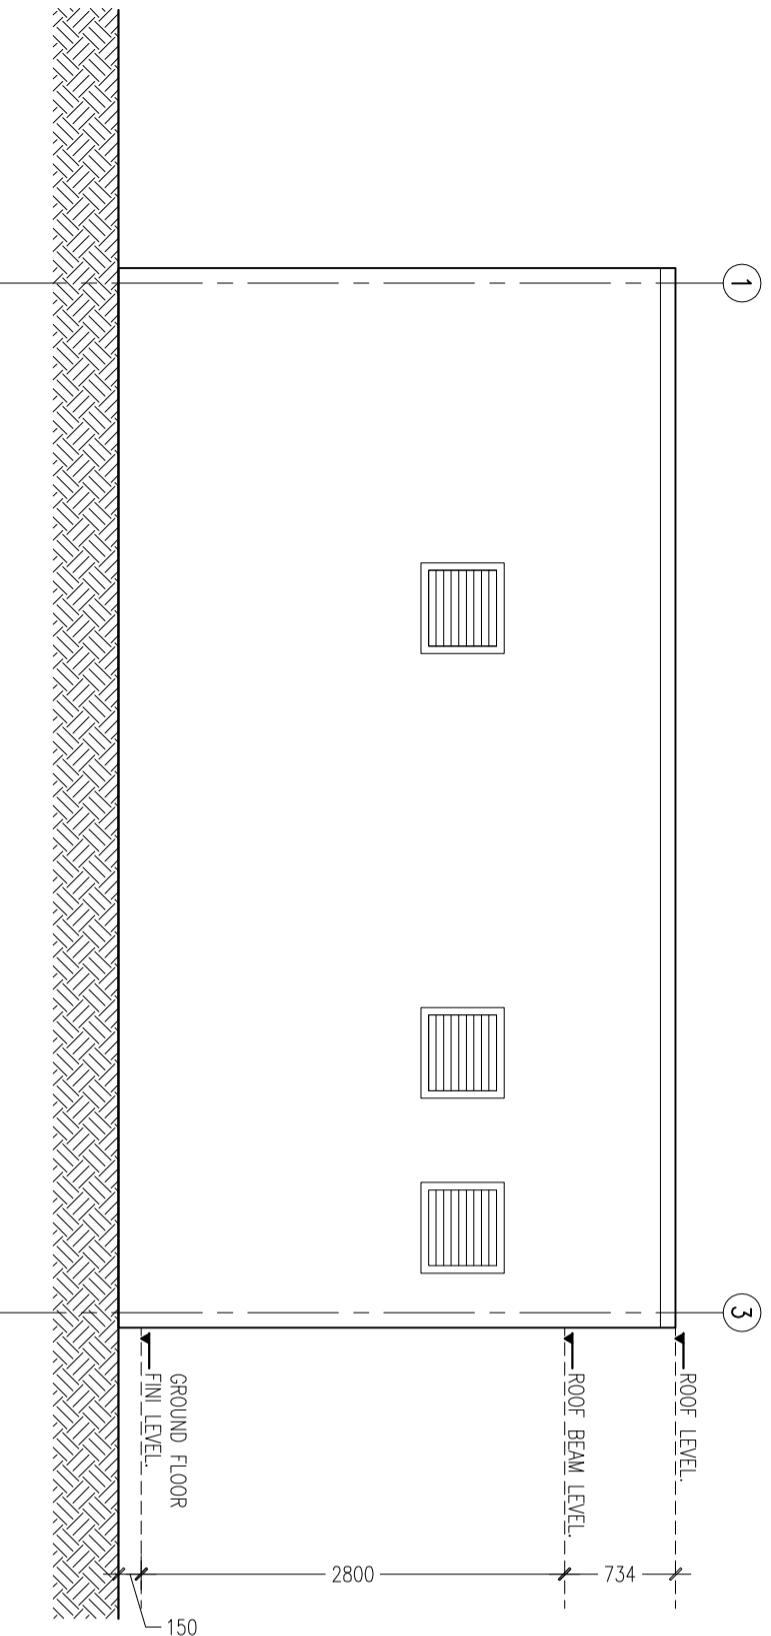

**ELEVATION-B**  
SCALE 1:50

LEGEND  
 EARTH  
 ROOFING SHEET

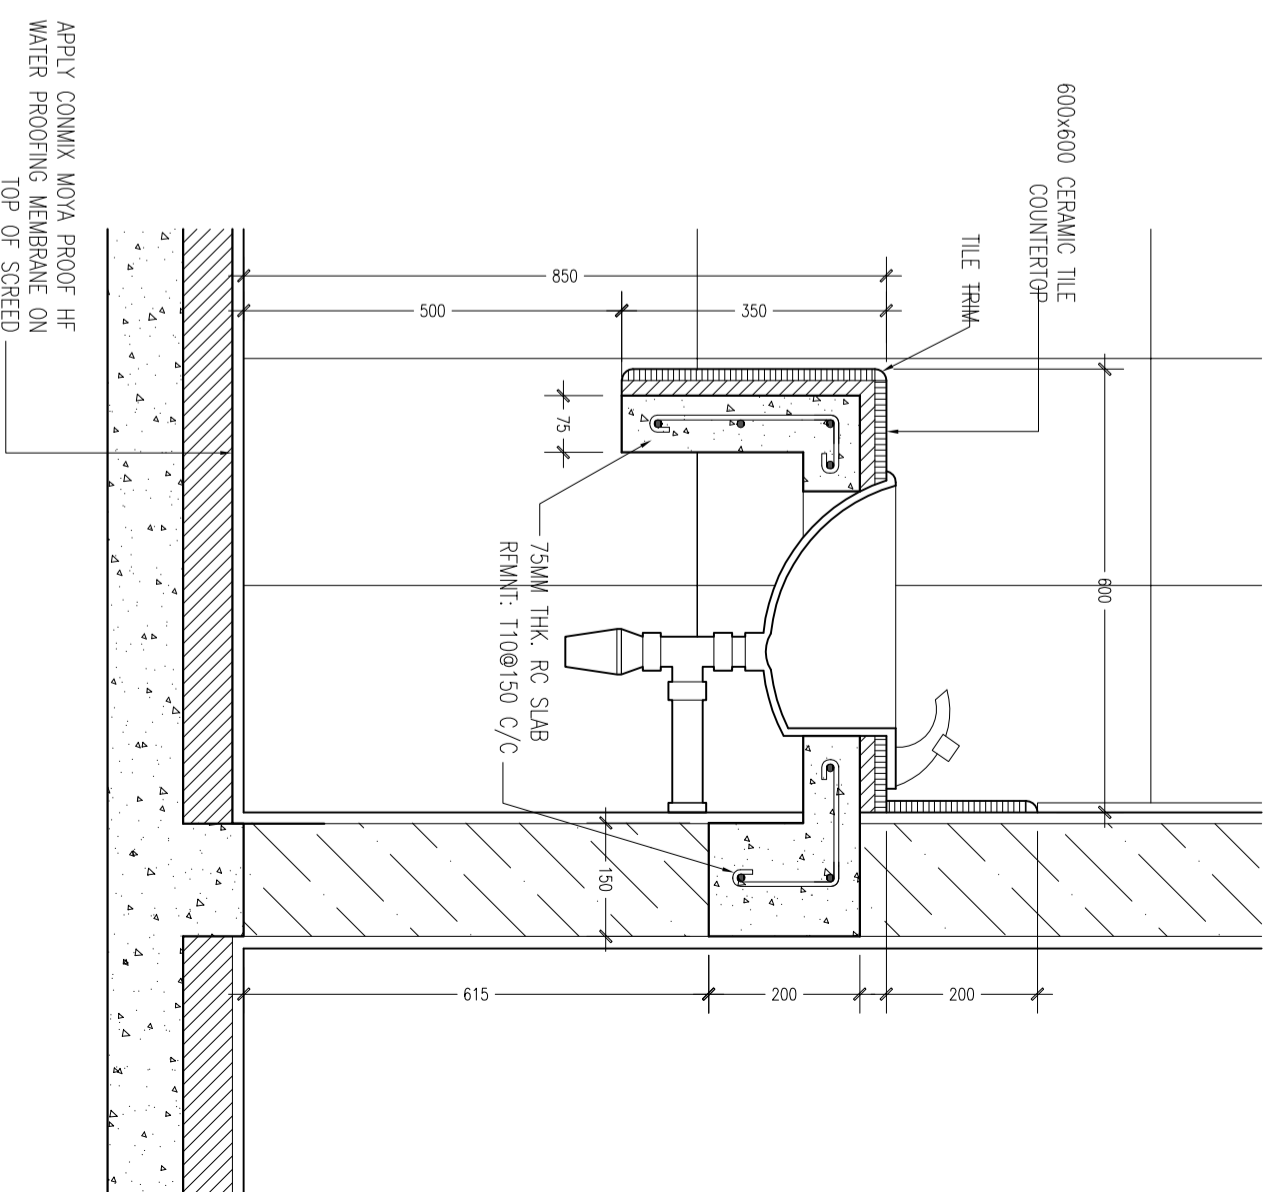


**LAVATORY DETAIL**  
SCALE 1:10

CONTRACTORS MUST CHECK ALL DIMENSIONS ON SITE BEFORE ANY WORK OR SHOP DRAWINGS. FIGURED DIMENSIONS TO TAKE PRECEDENCE OVER SCALE READINGS.

**ArchEng**  
 s t u d i o  
 No 17/A/2000, 1st floor, 'Maha', Republic of Maldives  
 archeng@archeng.mv


REVISION:	ARCHITECT:	PROJECT:	MALDIVES POLYTECHNIC, GAVILINGILU CAMPUS
	ENGINEER: MARIYAM SUWAH	LOCATION:	GAVILINGILU
	ARCHITECTURAL CHECKER:	DRAWING TITLE:	AS GIVEN
	STRUCTURAL CHECKER:	CLIENT:	MINISTRY OF HIGHER EDUCATION
	DRAWN BY: HANNA NISWA	SCALE: AS GIVEN	DIMENSION: MM
		DATE: SEPTEMBER 2021	
			PROJECT NO.: 21-001
			DWG NO.
			<b>A-09</b>

CONCEPT AND DESIGN IN THIS DRAWING ARE THE PROPERTIES OF ARCHING STUDIO PVT LTD. UNAUTHORIZED USE OR REPRODUCTION OF PART OF THE DESIGN/DRAWINGS OR CONCEPT TO USE IN OTHER PROJECTS OR SITES OTHER THAN SPECIFIED ON THIS DRAWING IS PROHIBITED

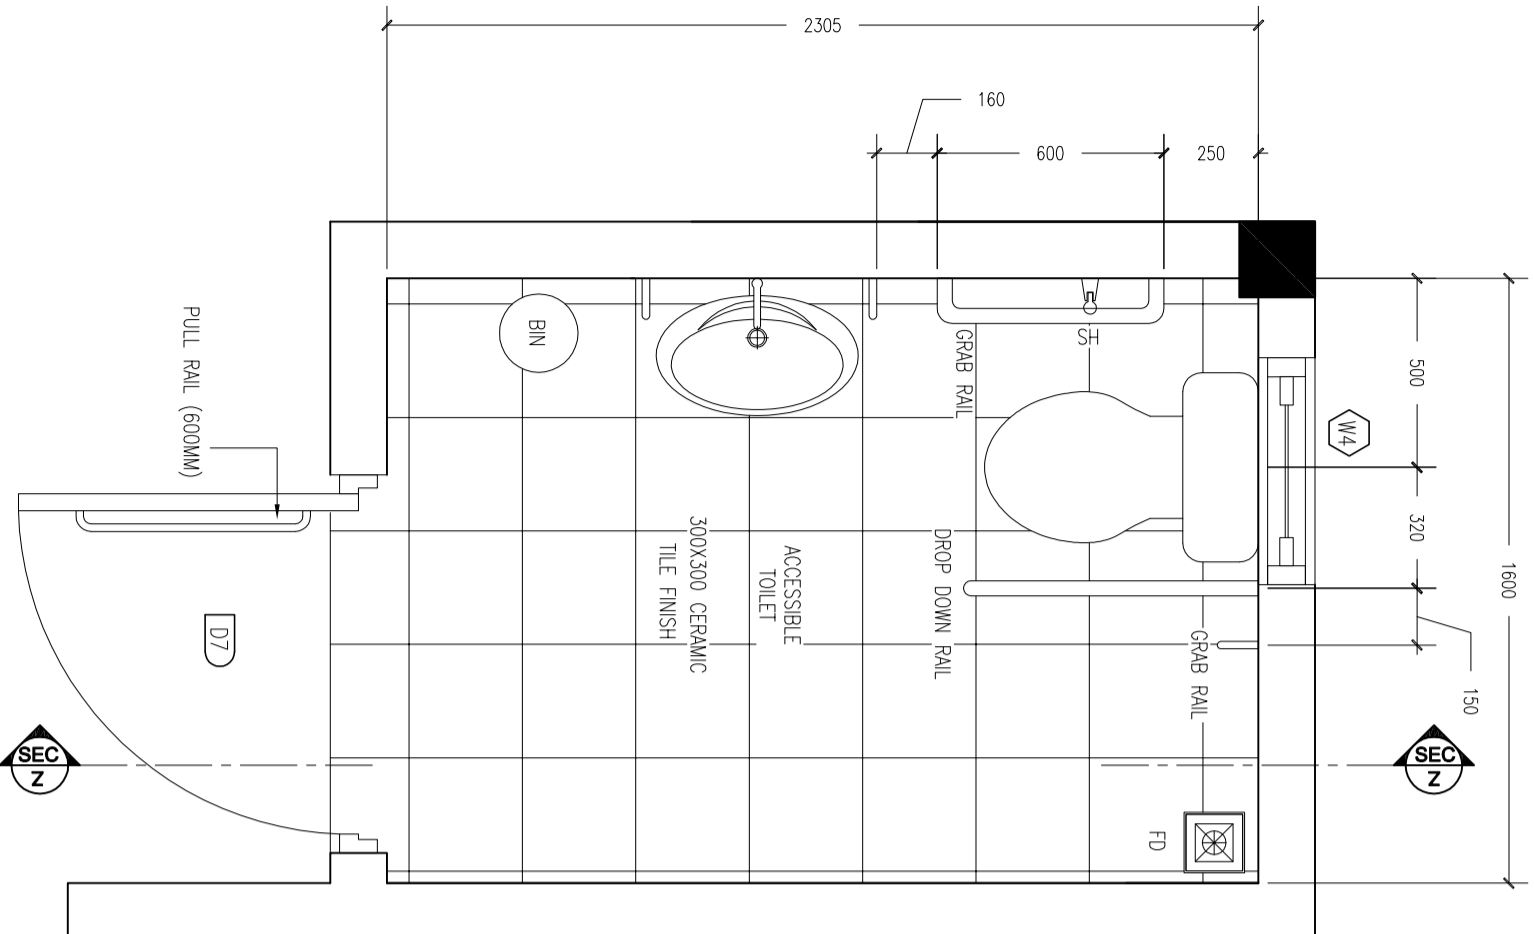


**ACCESSIBLE TOILET PLAN**  
SCALE 1:20

CONTRACTORS MUST CHECK ALL DIMENSIONS ON SITE BEFORE STARTING ANY WORK OR SHOP DRAWINGS FIGURED DIMENSIONS TO TAKE PRECEDENCE OVER SCALE REMAINS

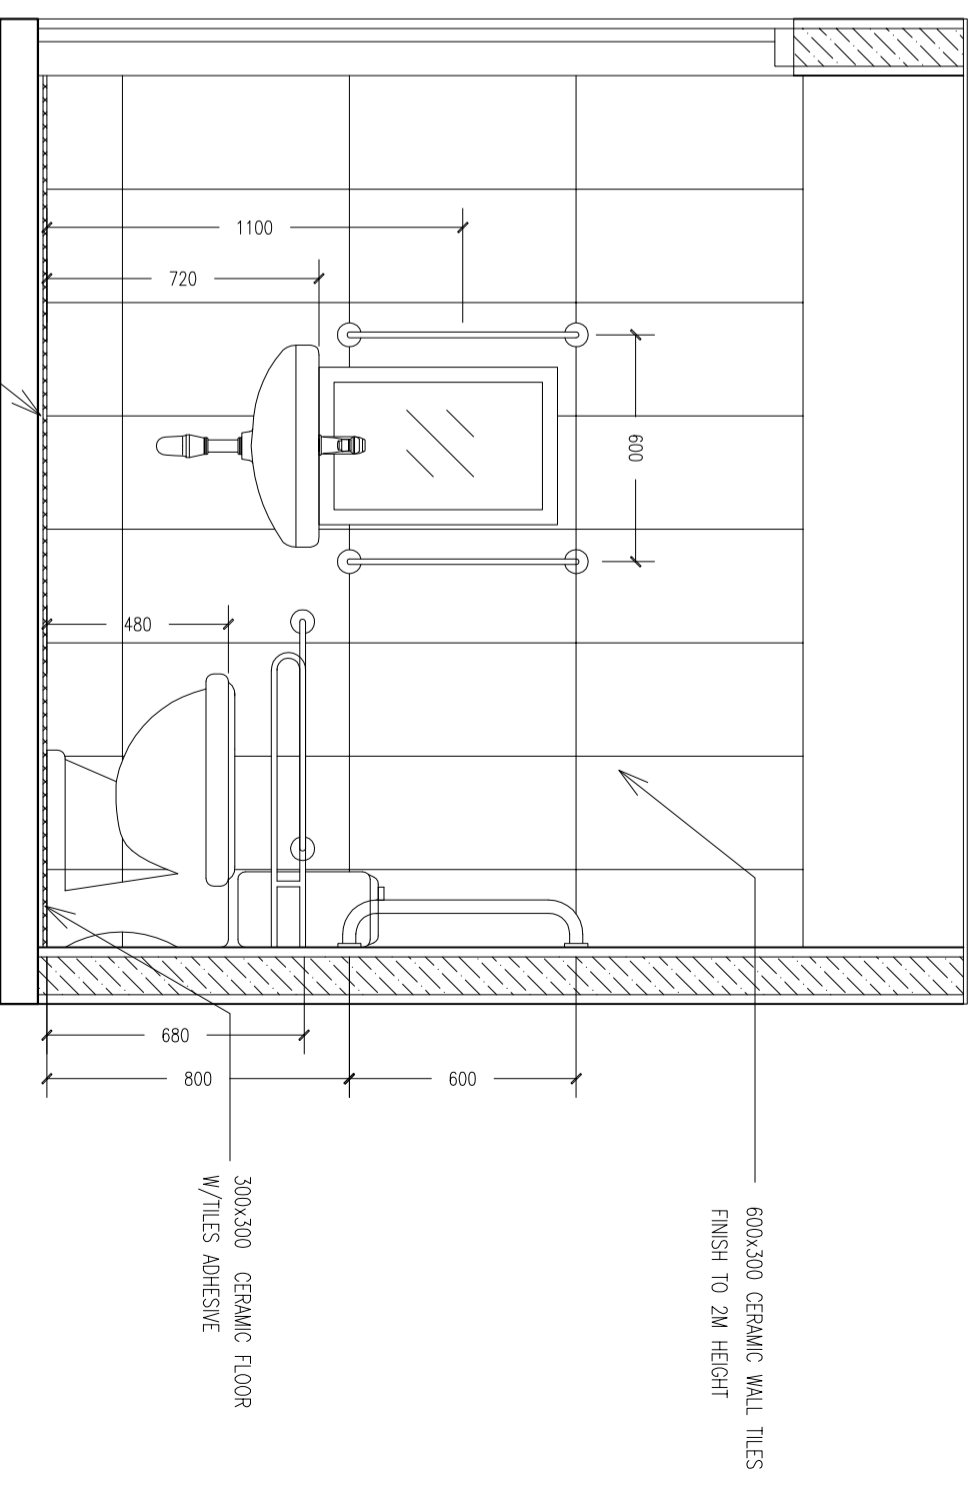

**SECTION-Z**  
SCALE 1:20

REVISION:	ARCHITECT:	PROJECT:	MALDIVES POLYTECHNIC, GA.VILINGILU CAMPUS
	ENGINEER:	LOCATION:	GA.VILINGILU
	ARCHITECTURAL CHECKER:	DRAWING TITLE:	AS GIVEN
	STRUCTURAL CHECKER:	CLIENT:	MINISTRY OF HIGHER EDUCATION
	DRAWN BY:	SCALE:	AS GIVEN
		DIMENSION:	MM
		DATE:	JUNE 2021
CONCEPT AND DESIGN IN THIS DRAWING ARE THE PROPERTIES OF ARCHENG STUDIO PVT.LTD. UNAUTHORIZED USE OR REPRODUCTION OF PART OF THE DESIGN/DRAWINGS OR CONCEPT TO USE IN OTHER PROJECTS OR SITES OTHER THAN SPECIFIED ON THIS DRAWING IS PROHIBITED		DWG NO	<b>A-10</b>
		PROJECT NO:	21-001

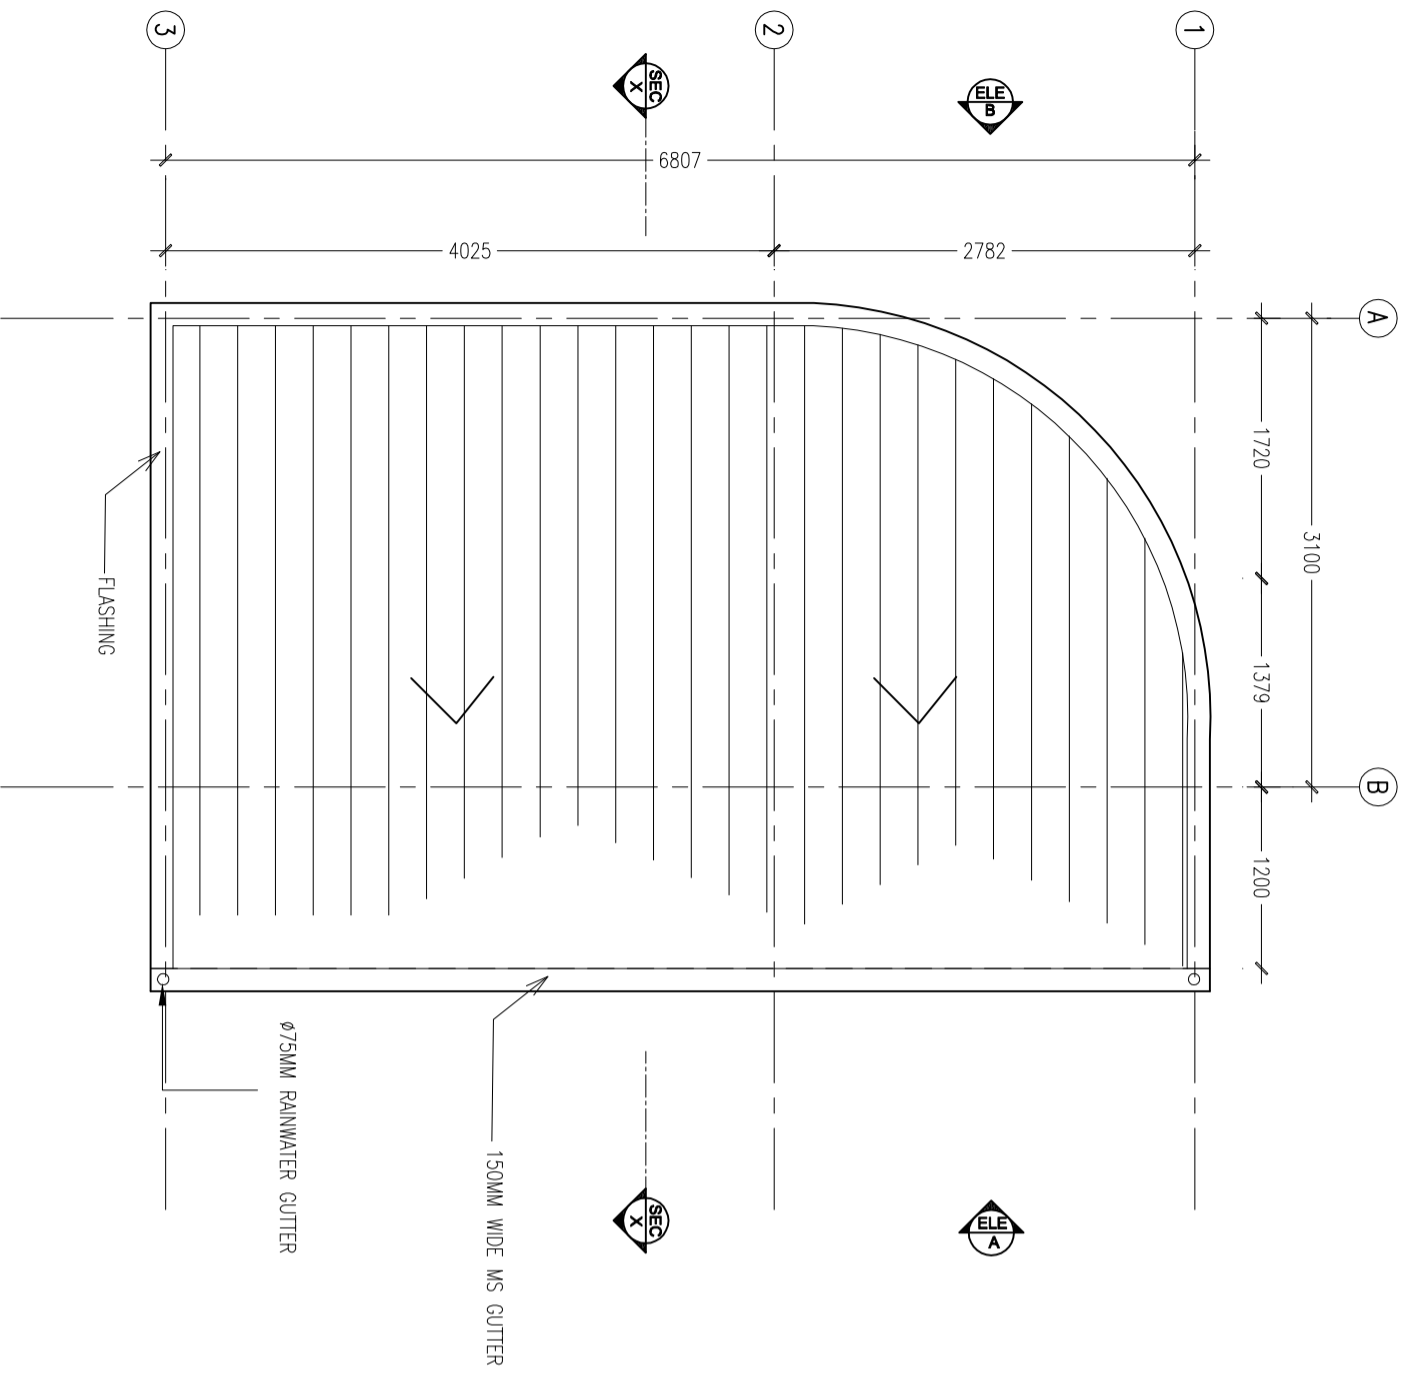

**ROOF PLAN**  
SCALE 1:50

DR / WD NO.	DESCRIPTION :	HARDWARE :	GLAZING :
D5	40MM THICK OPENABLE ALUMINIUM DOOR PANEL 40 MICRON WHITE POWDER COATED ALUMINIUM FRAME	DOOR CLOSER CYLINDRICAL LOCK BUTT HINGE STOPPER HOLDER	C-4MM
D6	40MM THICK OPENABLE ALUMINIUM DOOR PANEL 40 MICRON WHITE POWDER COATED ALUMINIUM FRAME	DOOR CLOSER CYLINDRICAL LOCK BUTT HINGE STOPPER HOLDER	C-4MM
D7	40MM THICK OPENABLE ALUMINIUM DOOR PANEL 40 MICRON WHITE POWDER COATED ALUMINIUM FRAME	DOOR CLOSER CYLINDRICAL LOCK BUTT HINGE STOPPER HOLDER	C-4MM

FINISH FLOOR LEVEL	DR / WD NO.	DESCRIPTION :	FRAME :	HARDWARE :	GLAZING :
	W4	ALUMINIUM FRAMED LOUVERS	80 MICRON WHITE POWDER COATED ALUMINIUM FRAME	01 NOS. LOUVERS WINDOW PANEL	-

ELEVATIONS :


  

NOTE :  
ALL TOILETS TO BE MECHANICALLY VENTILATED  
G-GLASS  
FG-FIXED GLASS


**PROPOSED DOOR/WINDOW SCHEDULE**  
SCALE 1:50

CONTRACTORS MUST CHECK ALL DIMENSIONS ON SITE BEFORE ANY WORK OR SHOP DRAWINGS FIGURED DIMENSIONS TO TAKE PRECEDENCE OVER SCALE READINGS

REVISION:	ARCHITECT:	PROJECT:
	MARIYAM SUWAH	MALDIVES POLYTECHNIC, GAVILINGILU CAMPUS
	ENGINEER:	GAVILINGILU
	ARCHITECTURAL CHECKER:	AS GIVEN
	STRUCTURAL CHECKER:	MINISTRY OF HIGHER EDUCATION
	DRAWN BY:	SCALE: AS GIVEN
	HANNA NISWA	DIMENSION: MM
		DATE: SEPTEMBER 2021
		PROJECT NO.: 21-001

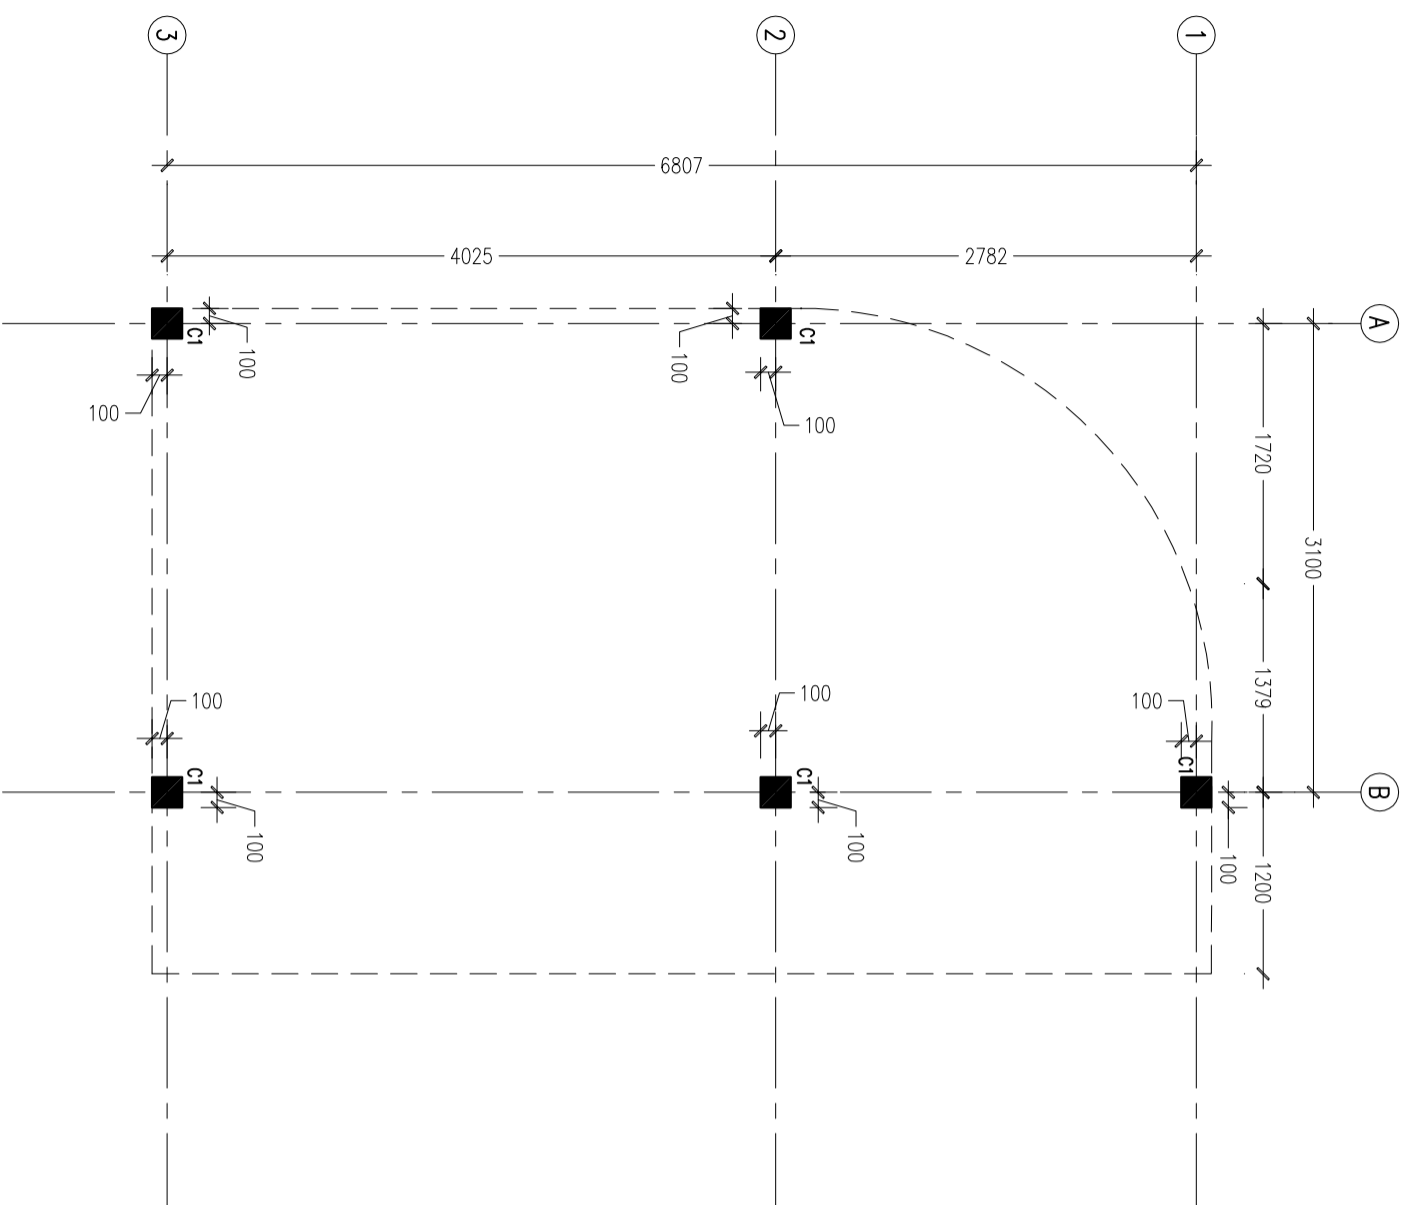

**COLUMN POSITION**  
SCALE 1:50

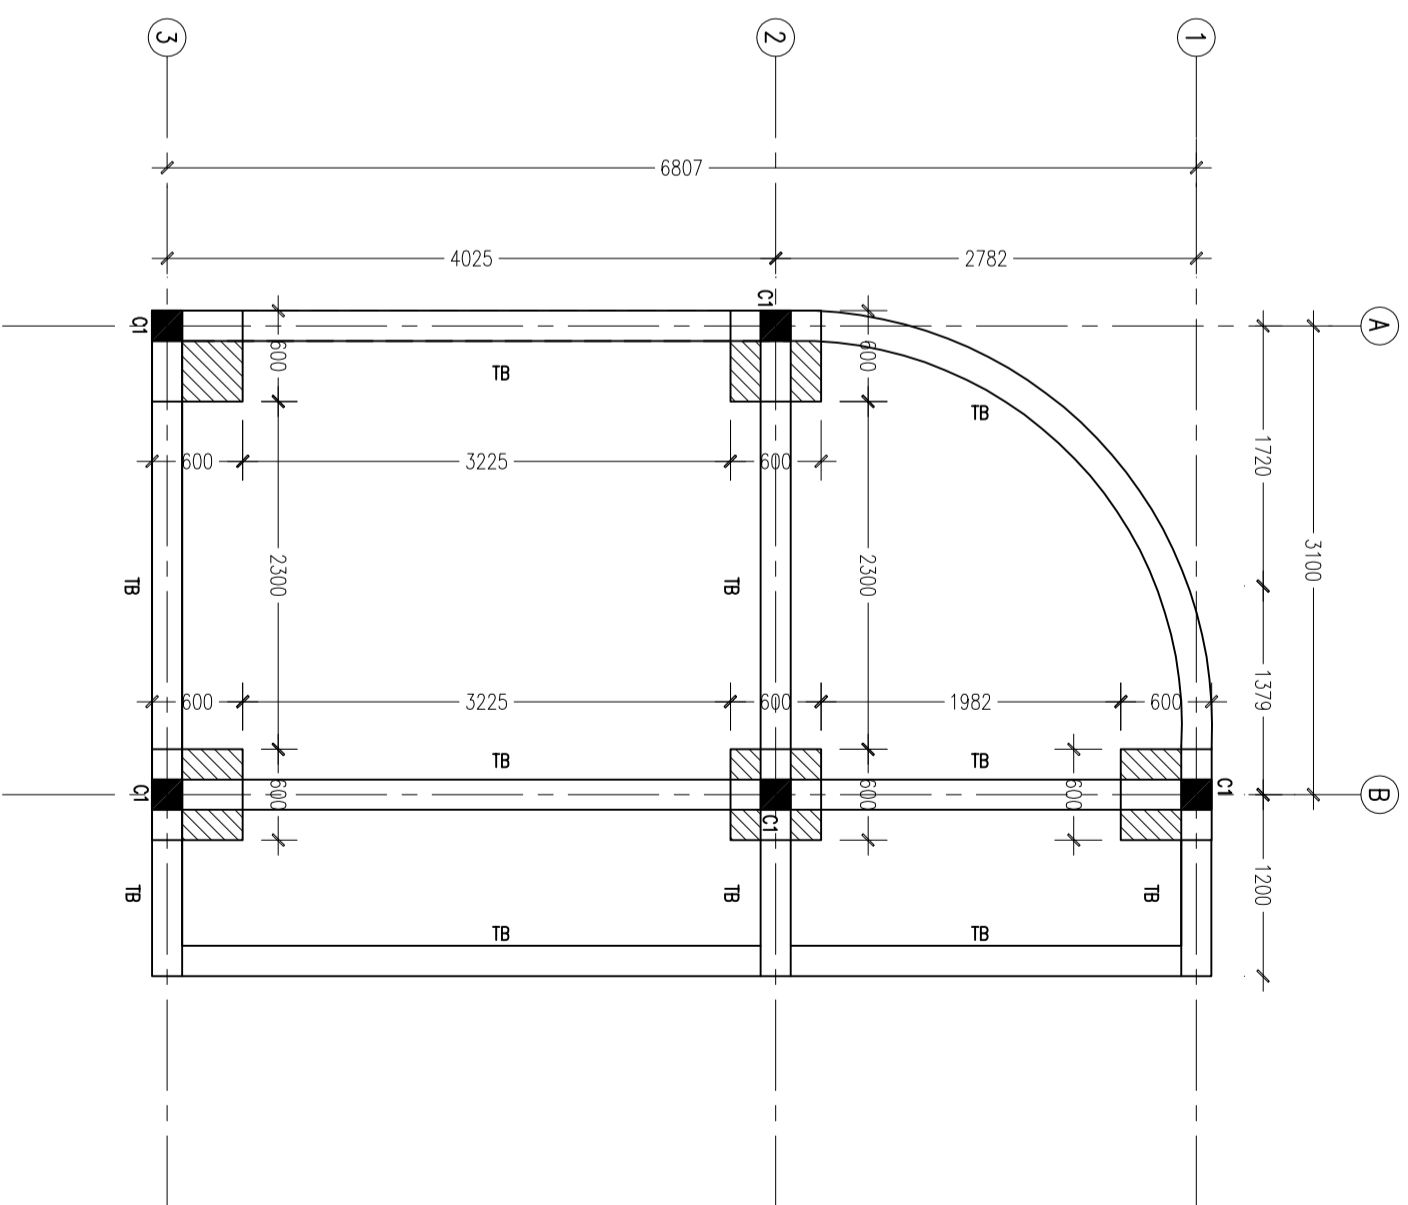


**FOUNDATION LAYOUT PLAN**  
SCALE 1:50


CONTRACTORS MUST CHECK ALL DIMENSIONS ON SITE BEFORE ANY WORK OR SHOP DRAWINGS, FIGURED DIMENSIONS TO TAKE PRECEDENCE OVER SCALE READINGS

REVISION:	ARCHITECT:	PROJECT:	MALDIVES POLYTECHNIC, GAUVILINGILU CAMPUS
	ENGINEER:	LOCATION:	GAUVILINGILU
	ARCHITECTURAL CHECKER:	DRAWING TITLE:	AS GIVEN
	STRUCTURAL CHECKER:	CLIENT:	MINISTRY OF HIGHER EDUCATION
	DRAWN BY:	SCALE:	AS GIVEN
		DIMENSION:	MM
		DATE:	SEPTEMBER 2021
		PROJECT NO.:	21-001
		DWG NO.:	S-02

CONCEPT AND DESIGN IN THIS DRAWING ARE THE PROPERTIES OF ARCHING STUDIO PVT LTD. UNAUTHORIZED USE OR REPRODUCTION OF PART OF THE DESIGN DRAWINGS OR CONCEPT TO USE IN OTHER PROJECTS OR SITES OTHER THAN SPECIFIED ON THIS DRAWING IS PROHIBITED

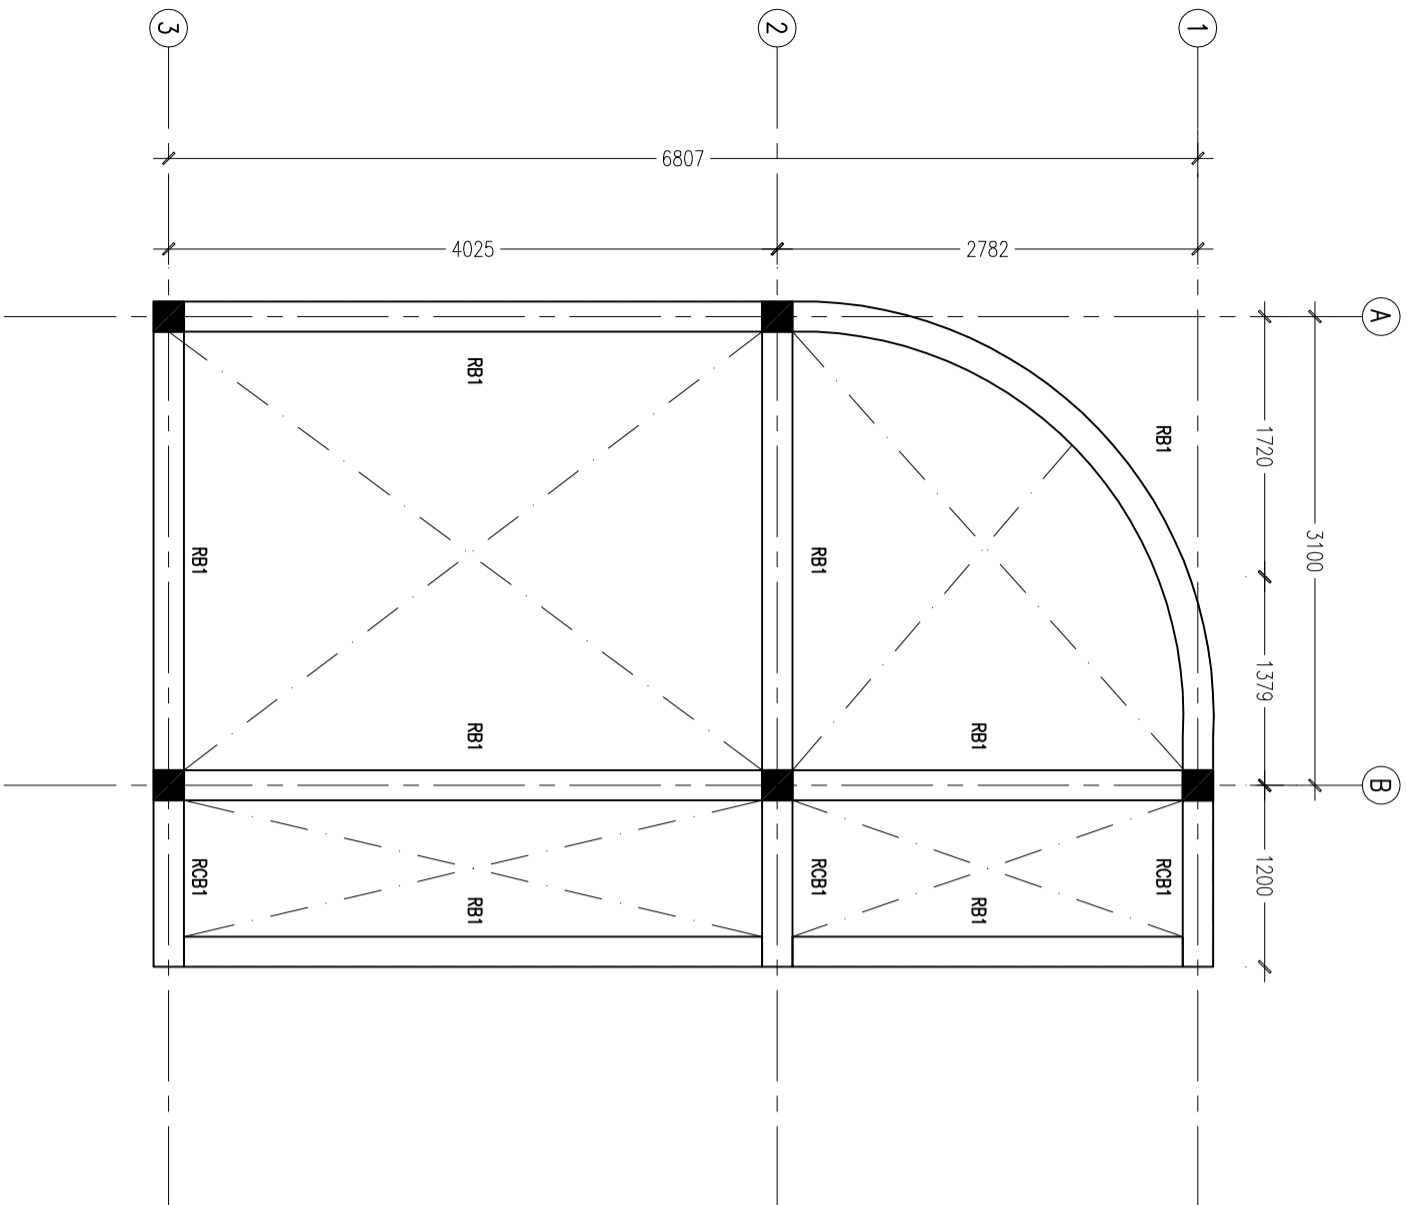

**ROOF BEAM PLAN**  
SCALE 1:50

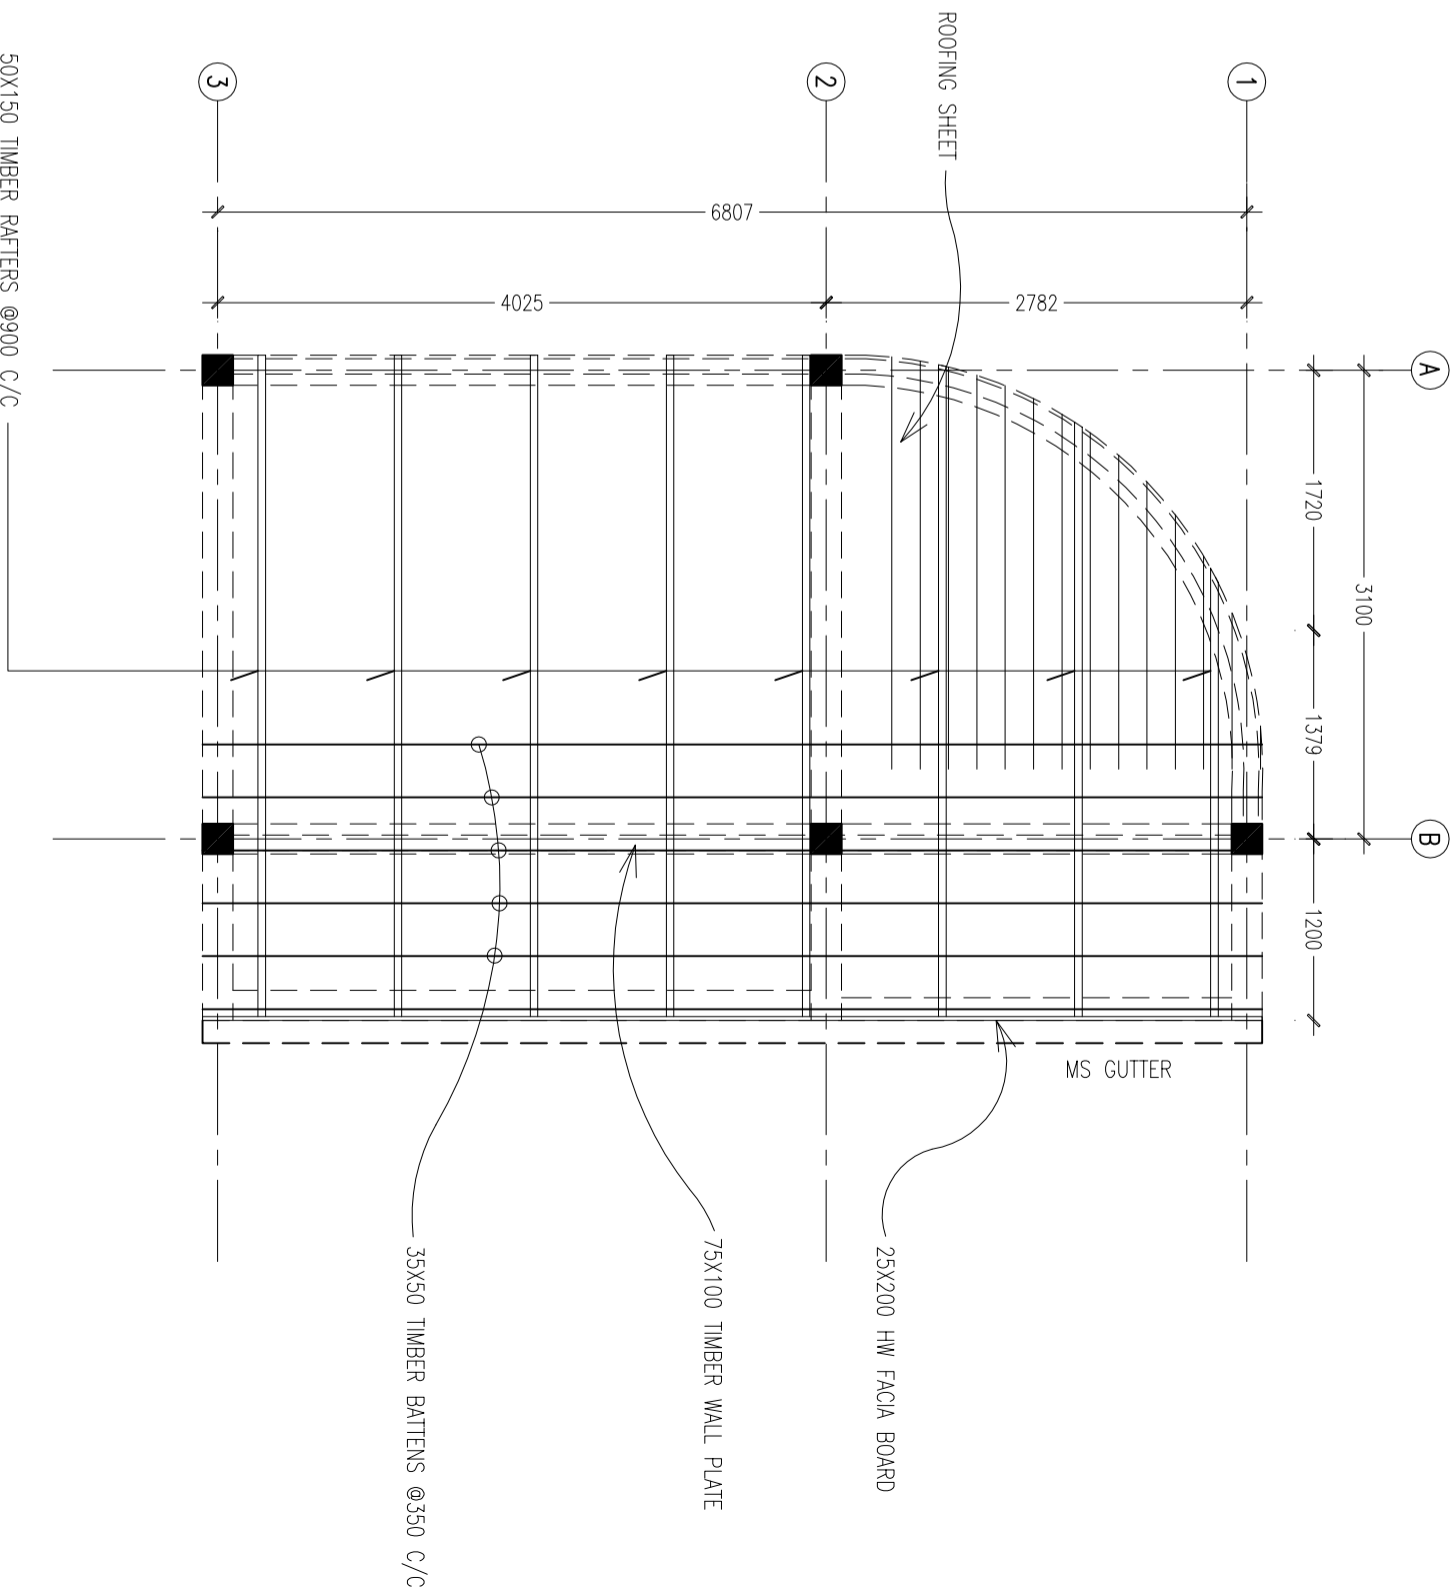


**ROOF STRUCTURE LAYOUT PLAN**  
SCALE 1:50

CONTRACTORS MUST CHECK ALL DIMENSIONS ON SITE BEFORE ANY WORK OR SHOP DRAWINGS TO TAKE PRECEDENCE OVER SCALE READINGS



REVISION:	ARCHITECT:	PROJECT:	MALDIVES POLYTECHNIC, GAVILINGILU CAMPUS
	ENGINEER: MARIYAM SAMA	LOCATION:	GAVILINGILU
	ARCHITECTURAL CHECKER:	DRAWING TITLE:	AS GIVEN
	STRUCTURAL CHECKER:	CLIENT:	MINISTRY OF HIGHER EDUCATION
	DRAWN BY: HANNA NISWA	SCALE: AS GIVEN	DIMENSION: MM
		DATE: SEPTEMBER 2021	PROJECT NO.: 21-001
			DWG NO.
			<b>S-03</b>






CONCEPT AND DESIGN IN THIS DRAWING ARE THE PROPERTIES OF ARCHING STUDIO PVT LTD. UNAUTHORIZED USE OR REPRODUCTION OF PART OF THE DESIGN/DRAWINGS OR CONCEPT TO USE IN OTHER PROJECTS OR SITES OTHER THAN SPECIFIED ON THIS DRAWING IS PROHIBITED

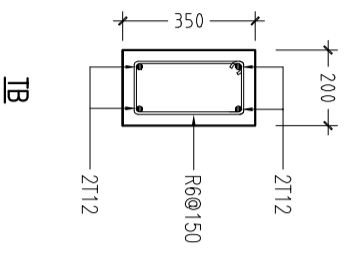

FOOTING	LENGTH/mm	WIDTH/mm	DEPTH/mm	REINFORCEMENT
F1	600	600	250	T10@150mm-B-BW

**FOUNDATION BEAM**

**FOUNDATION FOOTING DETAIL**

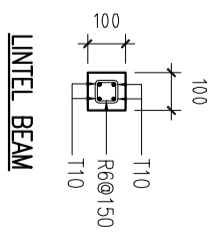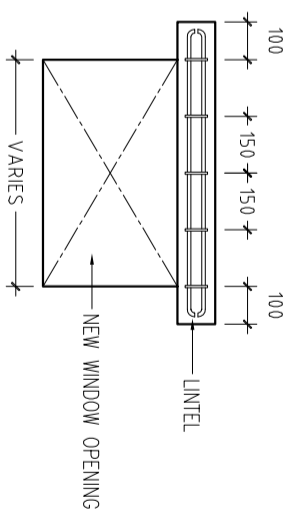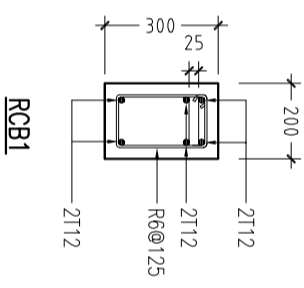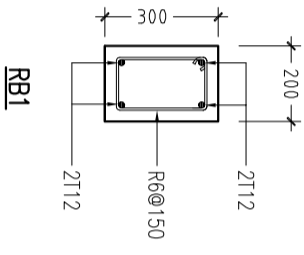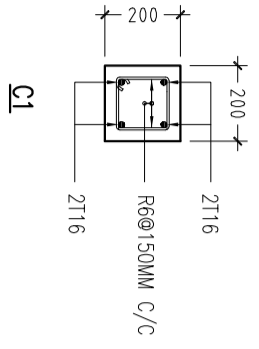

**COLUMN DETAIL**

**ROOF BEAM DETAIL**


**LINTEL DETAIL**

SCALE 1:20

SCALE 1:20


SCALE 1:20

CONTRACTORS MUST CHECK ALL DIMENSIONS ON SITE BEFORE STARTING ANY WORK OR SHOP DRAWINGS. FIGURED DIMENSIONS TO TAKE PRECEDENCE OVER SCALE READINGS

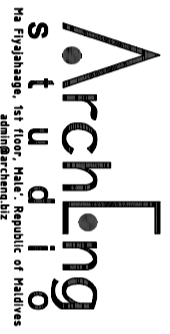


REVISION:	ARCHITECT:	PROJECT:	DWG NO
	MARIYAM SAMAH	MAADIVES POLYTECHNIC, GA.VILINGILU CAMPUS	<b>S-04</b>
	ARCHITECTURAL CHECKER:	LOCATION: GA.VILINGILU	PROJECT NO: 21-001
	STRUCTURAL CHECKER:	DRAWING TITLE: AS GIVEN	
	HANWVA NISWA	CLIENT: MINISTRY OF HIGHER EDUCATION	
		SCALE: AS GIVEN	
		DIMENSION: MM	
		DATE: SEPTEMBER 2021	


CONCEPT AND DESIGN IN THIS DRAWING ARE THE PROPERTIES OF ARCHENG STUDIO PVT.LTD. UNAUTHORIZED USE OR REPRODUCTION OF PART OF THE DESIGN DRAWINGS OR CONCEPT TO USE IN OTHER PROJECTS OR SITES OTHER THAN SPECIFIED ON THIS DRAWING IS PROHIBITED

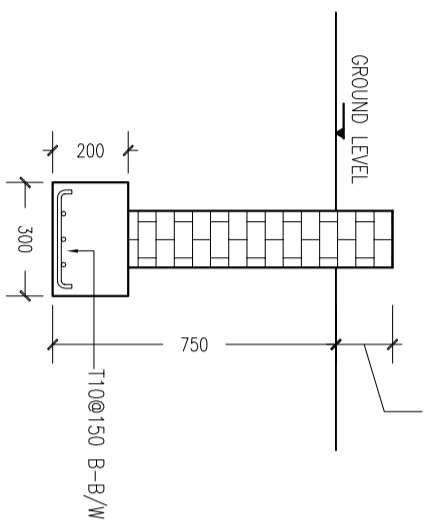


**BOUNDARY WALL FOOTING**  
SCALE 1:20

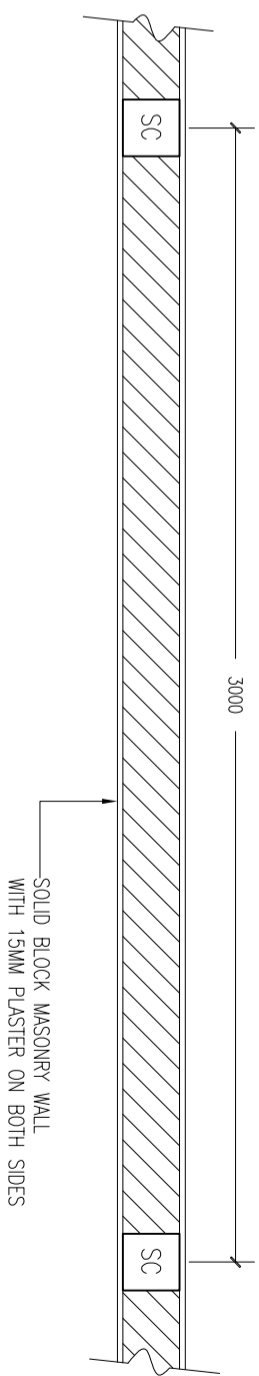


**TYPICAL BOUNDARY WALL DETAIL-PLAN**  
SCALE 1:20

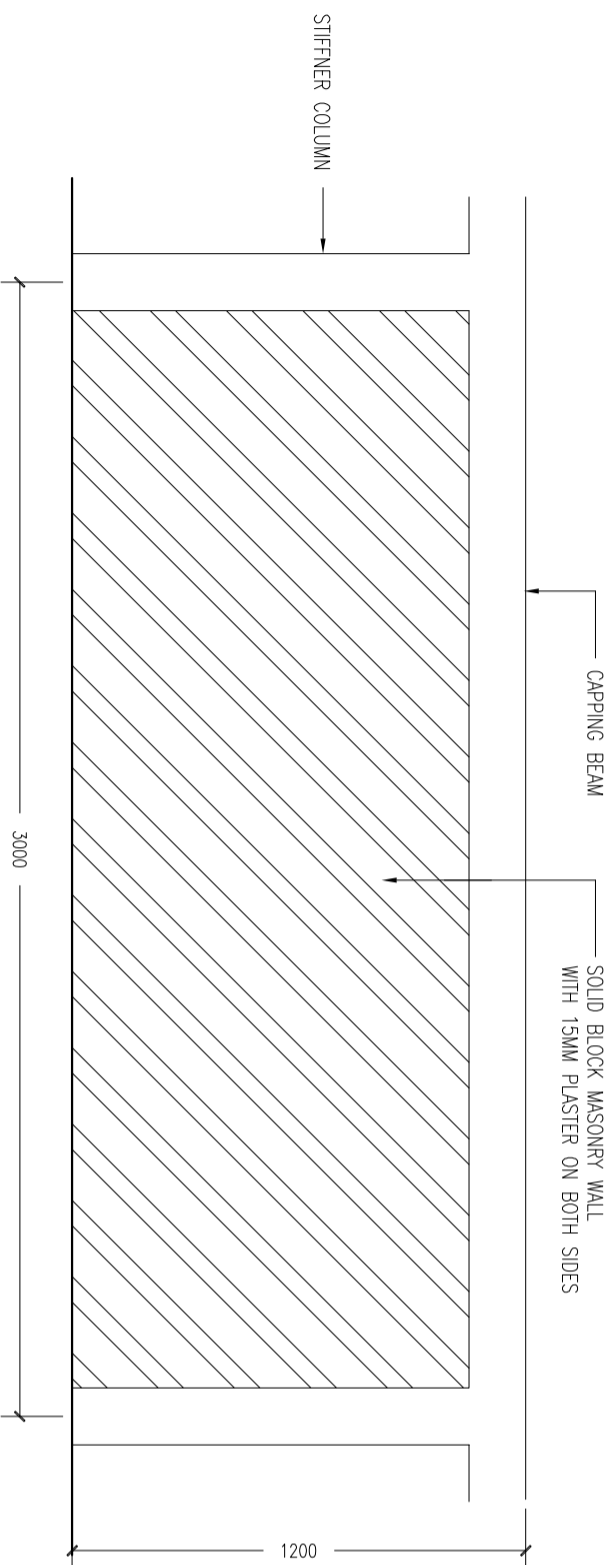

**TYPICAL BOUNDARY - WALL DETAIL ELEVATION**  
SCALE 1:20

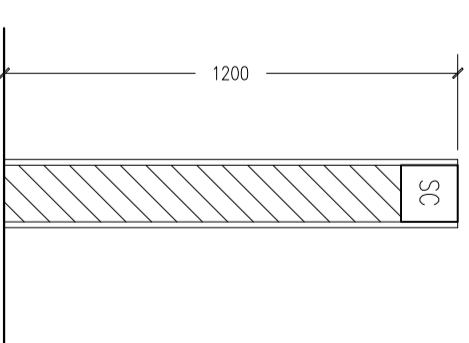

**TYPICAL BOUNDARY WALL DETAIL SECTION**  
SCALE 1:20


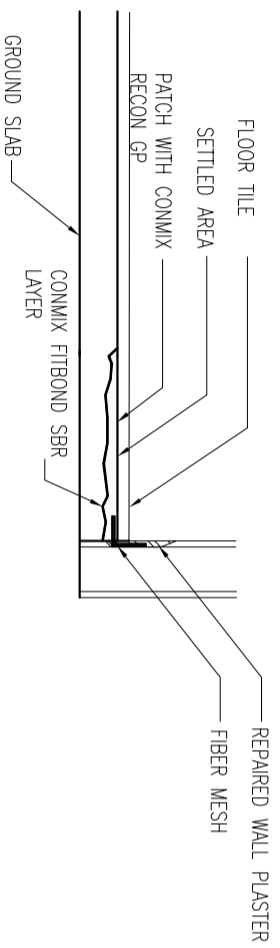


**SLAB REPAIR DETAILS**  
SCALE 1:20

CONTRACTORS MUST CHECK ALL DIMENSIONS ON SITE BEFORE STARTING ANY WORK OR SHOP DRAWINGS. FIGURED DIMENSIONS TO TAKE PRECEDENCE OVER SCALE READINGS

REVISION:	ARCHITECT:	PROJECT:	MALDIVES POLYTECHNIC, GAVILINGILU CAMPUS
	ENGINEER:	LOCATION:	GAVILINGILU
	ARCHITECTURAL CHECKER:	DRAWING TITLE:	AS GIVEN
	STRUCTURAL CHECKER:	CLIENT:	MINISTRY OF HIGHER EDUCATION
	DRAWN BY:	SCALE: AS GIVEN	DIMENSION: MM
		DATE: SEPTEMBER 2021	
CONCEPT AND DESIGN IN THIS DRAWING ARE THE PROPERTIES OF ARCHENG STUDIO PVT LTD. UNAUTHORIZED USE OR REPRODUCTION OF PART OF THE DESIGN DRAWINGS OR CONCEPT TO USE IN OTHER PROJECTS OR SITES OTHER THAN SPECIFIED ON THIS DRAWING IS PROHIBITED			DWG NO
			PROJECT NO: 21-001
			<b>S-05</b>



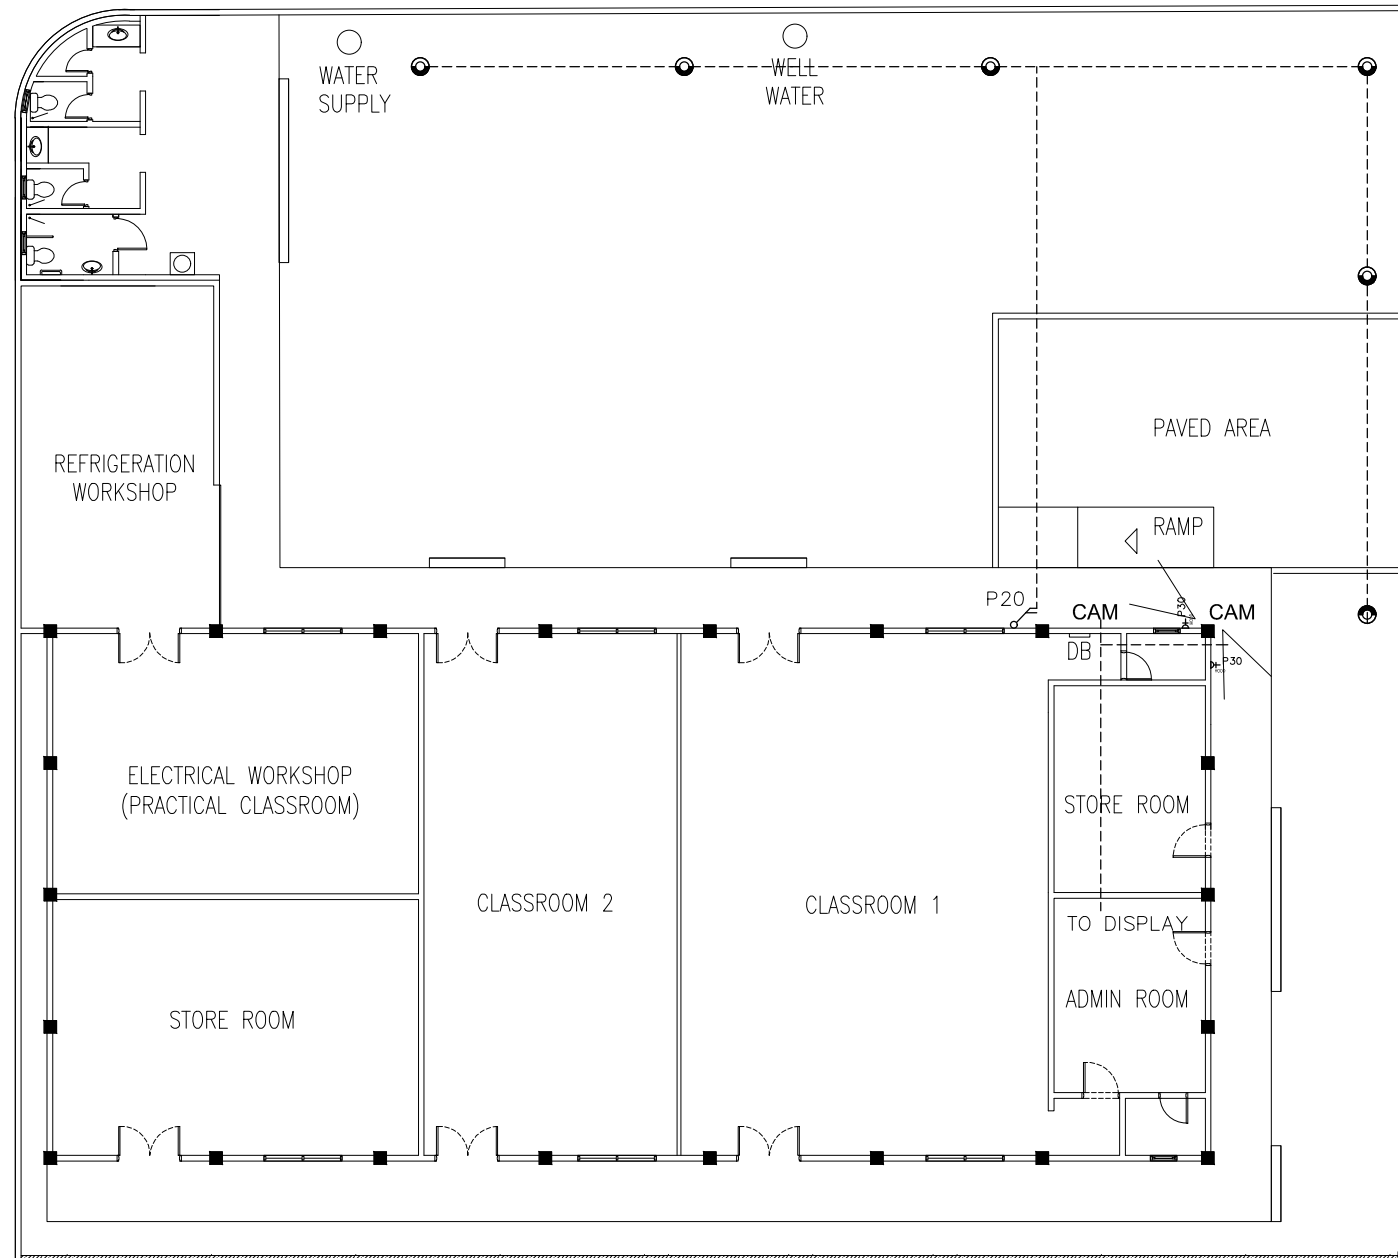 

**LEGEND**

- ☉ WHITE LED GARDEN LIGHT
- CAM CCTV CAMERA

**SWITCHES LEGEND**

	P20	2GANG 1 WAY SWITCH
--	-----	--------------------

**SOCKET LEGEND**

	P30	1 GANG13A SOCKET OUTLET AT CEILING LEVEL FOR KITCHEN HOOD /EXHAUST - 2.1 METERS FFL
--	-----	---

**LIGHTING AND CAMERA LAYOUT PLAN**

SCALE 1:200

CONTRACTORS MUST CHECK ALL DIMENSIONS ON SITE BEFORE STARTING ANY WORK OR SHOP DRAWINGS, FIGURED DIMENSIONS TO TAKE PRECEDENCE OVER SCALE READINGS




REVISION:	ARCHITECT:	PROJECT:
	ENGINEER: MARIYAM SAMAH	LOCATION: GA,VILLINGILI
	ARCHITECTURAL CHECKER:	DRAWING TITLE: AS GIVEN
	STRUCTURAL CHECKER:	CLIENT: MINISTRY OF HIGHER EDUCATION
	DRAWN BY: HAWWA NISWA	SCALE: AS GIVEN    DIMENSION: MM    DATE: SEPTEMBER 2021

PROJECT:	MALDIVES POLYTECHNIC, GA,VILLINGILI CAMPUS
LOCATION:	GA,VILLINGILI
DRAWING TITLE:	AS GIVEN
CLIENT:	MINISTRY OF HIGHER EDUCATION
SCALE:	AS GIVEN    DIMENSION: MM    DATE: SEPTEMBER 2021

**E-01**  
DWG NO  
PROJECT NO: 21-001

CONCEPT AND DESIGN IN THIS DRAWING ARE THE PROPERTIES OF ARCHENG STUDIO PVT LTD. UNAUTHORIZED USE OR REPRODUCTION OF PART OF THE DESIGN, DRAWINGS OR CONCEPT TO USE IN OTHER PROJECTS OR SITES OTHER THAN SPECIFIED ON THIS DRAWING IS PROHIBITED

 


### LIGHTING LEGEND

SYMBOL	CODE	DESCRIPTION
	L07	3x36W FLUORESCENT LAMPS IN SURFACE MOUNT LUMINAIRE WITH DIFFUSER

### SWITCHES LEGEND

SYMBOL	CODE	DESCRIPTION
	P21	3GANG 1 WAY SWITCH
	P33	DISTRIBUTION BOARD

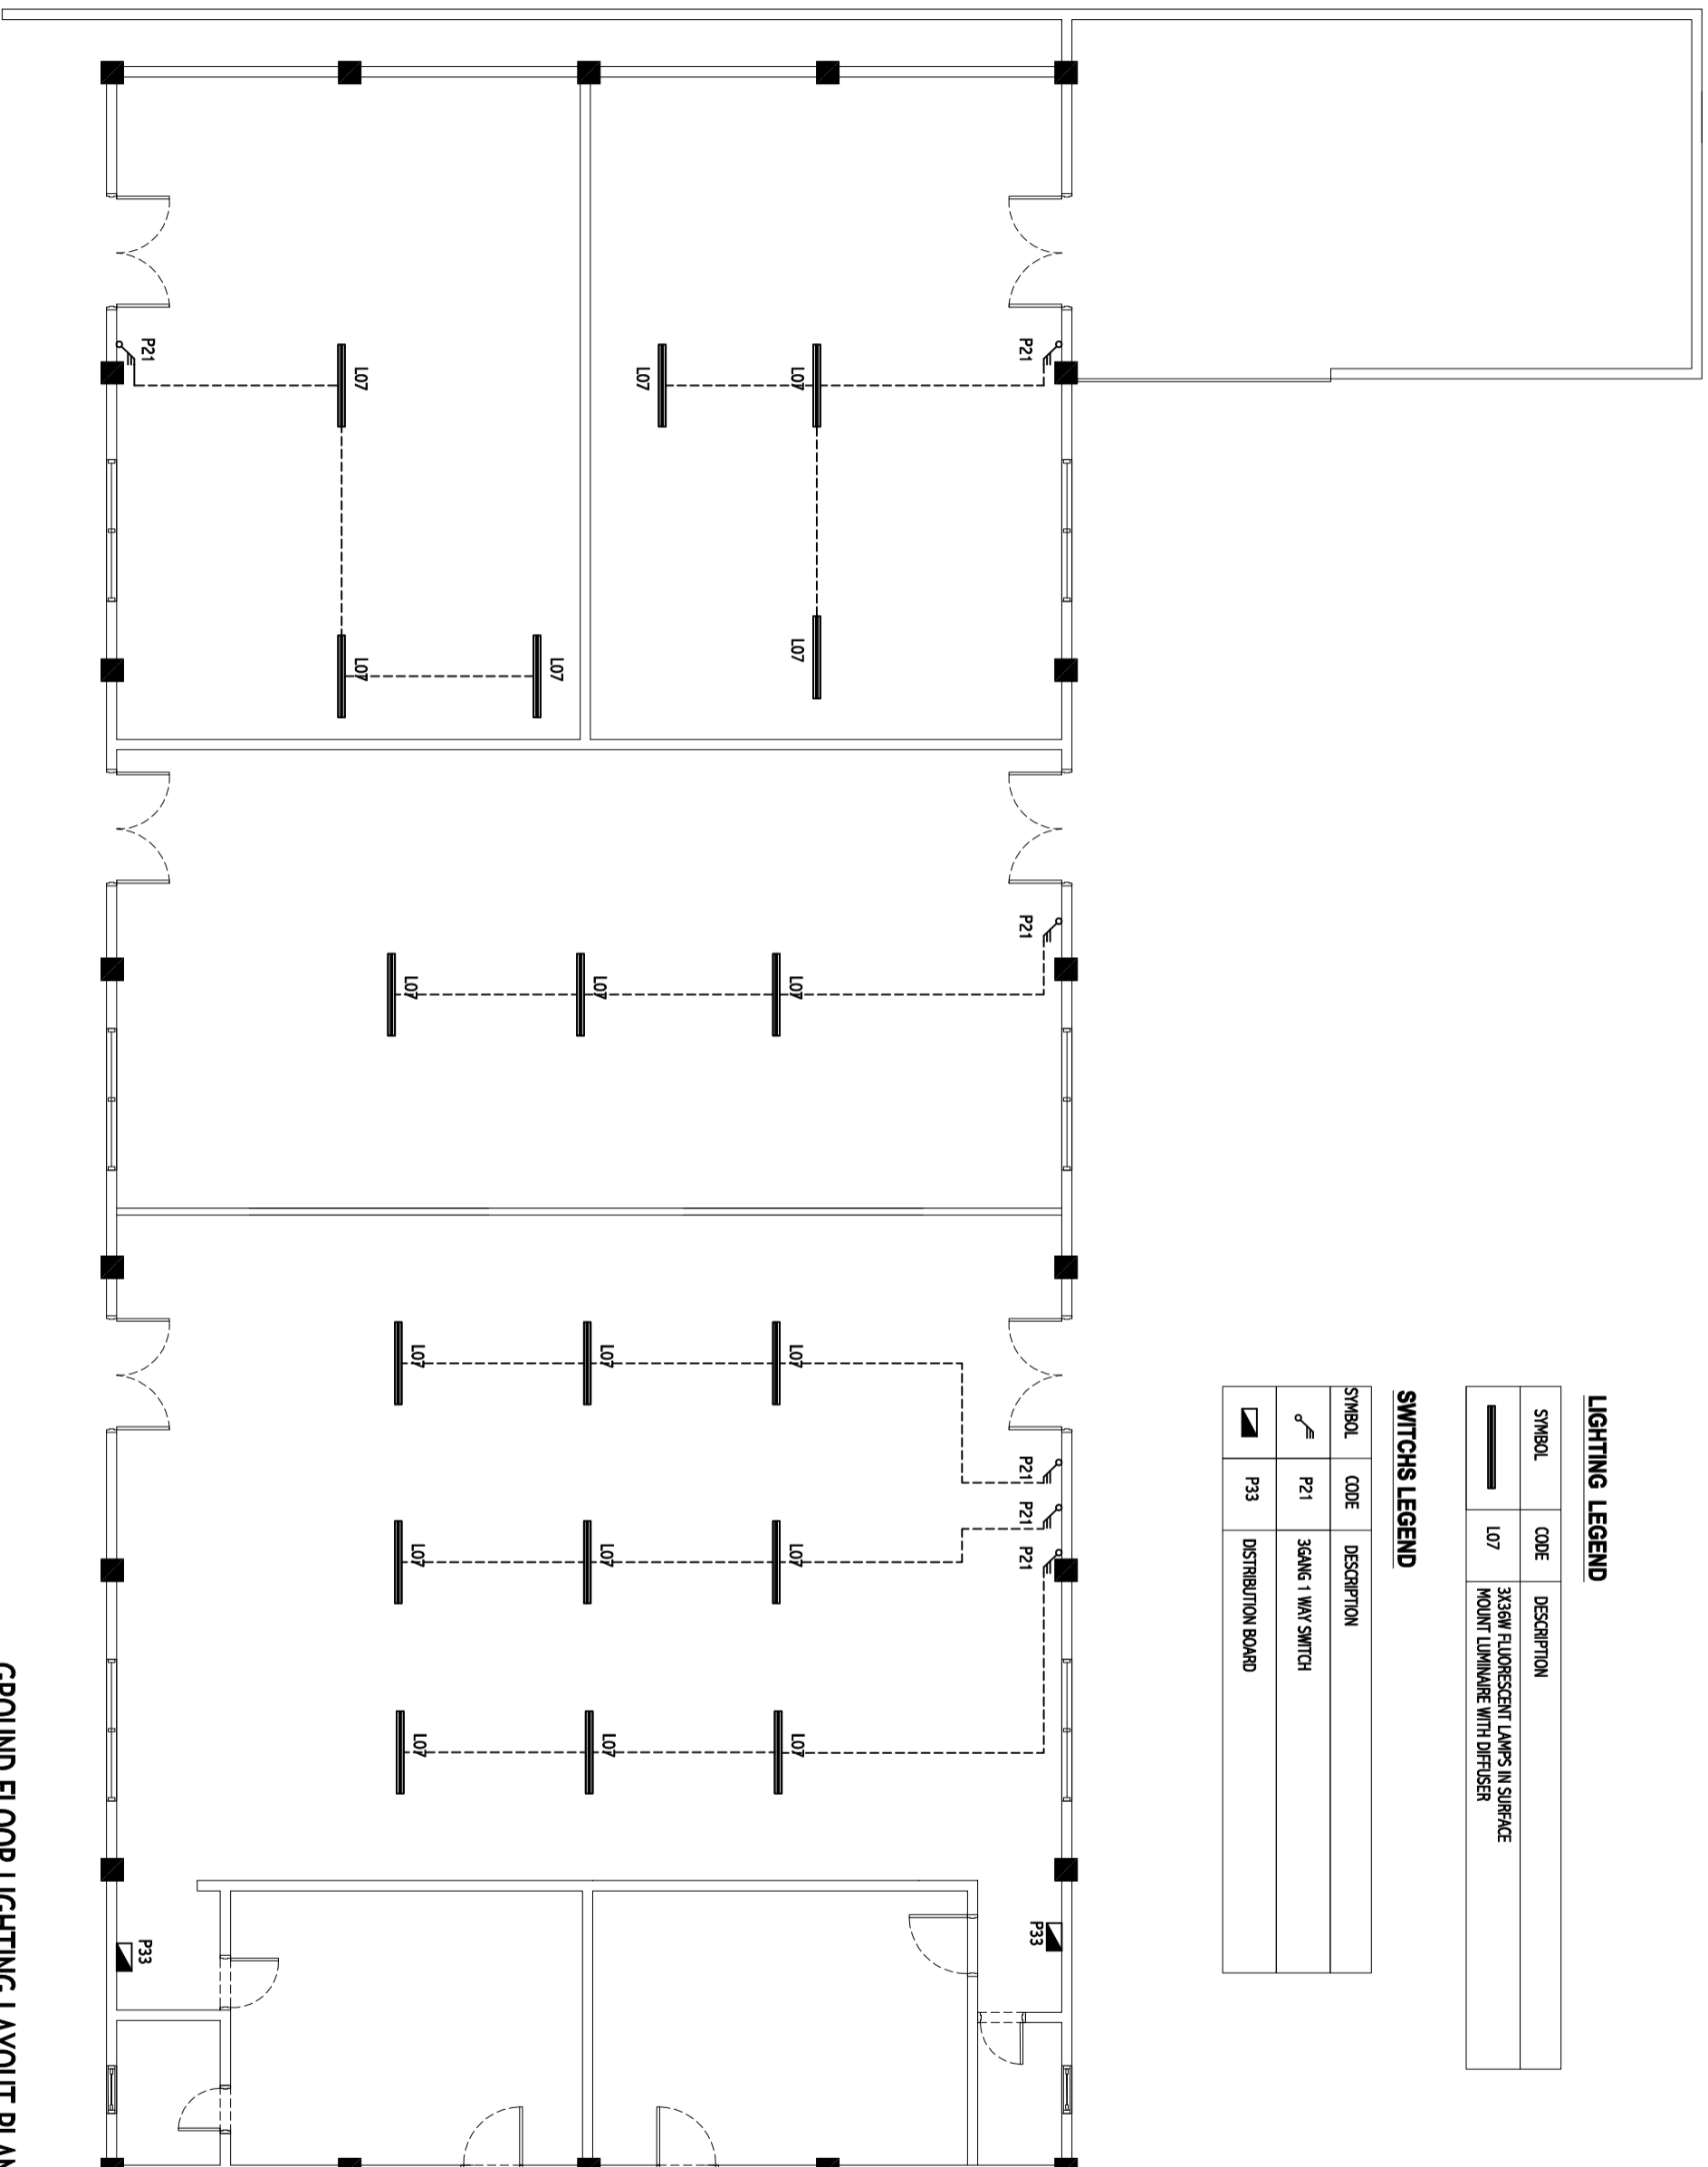

## GROUND FLOOR LIGHTING LAYOUT PLAN

SCALE 1:100

CONTRACTORS MUST CHECK ALL DIMENSIONS ON SITE BEFORE STARTING ANY WORK OR SHOP DRAWINGS. FIGURED DIMENSIONS TO TAKE PRECEDENCE OVER SCALE READINGS





REVISION:	ARCHITECT:	PROJECT:	DWG NO
	ENGINEER: MARIYAM SAMAH	MADIVES POLYTECHNIC, GA.VILLINGILI CAMPUS	<b>E-02</b>
	ARCHITECTURAL CHECKER:	LOCATION: GA.VILLINGILI	PROJECT NO: 21-001
	STRUCTURAL CHECKER:	DRAWING TITLE: AS GIVEN	
	DRAWN BY: HAMWA NISWA	CLIENT: MINISTRY OF HIGHER EDUCATION	
		SCALE: AS GIVEN	
		DIMENSION: MM	
		DATE: SEPTEMBER 2021	

CONCEPT AND DESIGN IN THIS DRAWING ARE THE PROPERTIES OF ARCHENG STUDIO PVT.LTD. UNAUTHORIZED USE OR REPRODUCTION OF PART OF THE DESIGN DRAWINGS OR CONCEPT TO USE IN OTHER PROJECTS OR SITES OTHER THAN SPECIFIED ON THIS DRAWING IS PROHIBITED

**ELECTRICAL LEGEND**

 SYMBOL	CODE	DESCRIPTION
	VO1b	ØM 1200 CEILING FAN
	P23	FAN 4 GWS SWITCH

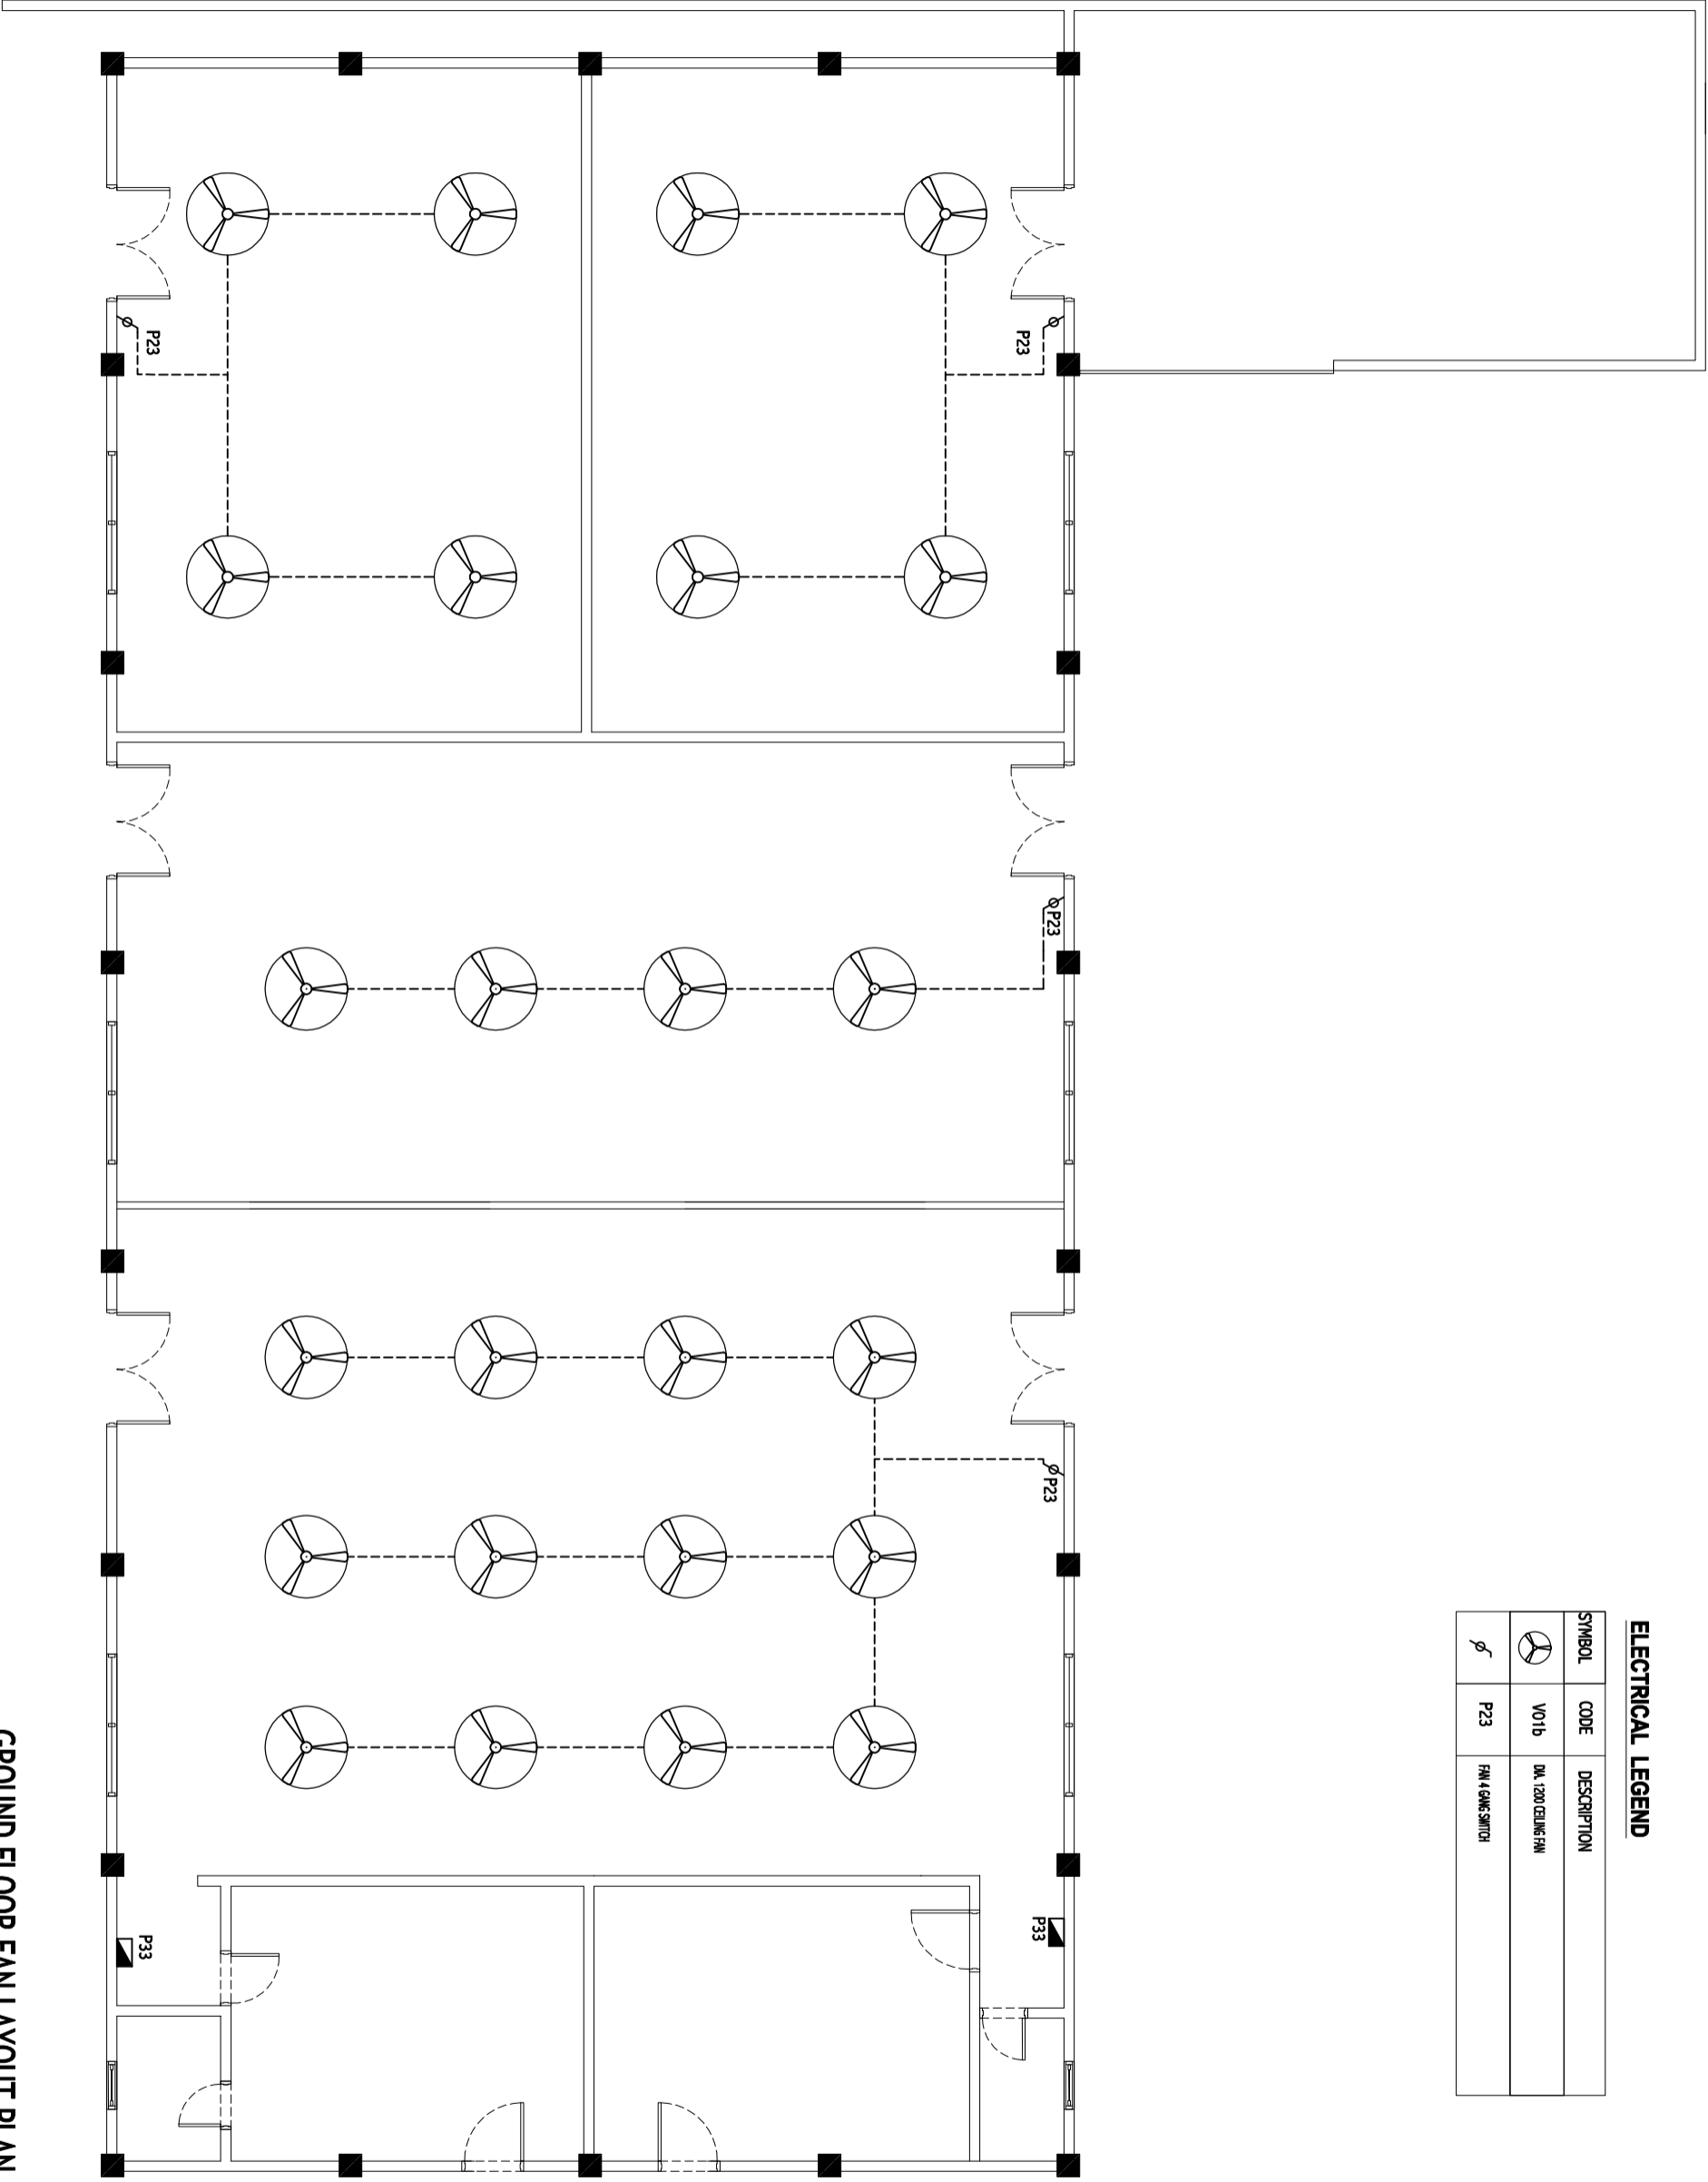

**GROUND FLOOR FAN LAYOUT PLAN**


SCALE 1:100

CONTRACTORS MUST CHECK ALL DIMENSIONS ON SITE BEFORE STARTING ANY WORK OR SHOP DRAWINGS. FIGURED DIMENSIONS TO TAKE PRECEDENCE OVER SCALE READINGS



REVISION:	ARCHITECT:	PROJECT:	MALDIVES POLYTECHNIC, GA.VILLINGILI CAMPUS
	ENGINEER:	LOCATION:	GA.VILLINGILI
	ARCHITECTURAL CHECKER:	DRAWING TITLE:	AS GIVEN
	STRUCTURAL CHECKER:	CLIENT:	MINISTRY OF HIGHER EDUCATION
	DRAWN BY:	SCALE:	AS GIVEN
		DIMENSION:	MM
		DATE:	SEPTEMBER 2021
		PROJECT NO.:	21-001
		DWG NO.:	<b>E-03</b>

CONCEPT AND DESIGN IN THIS DRAWING ARE THE PROPERTIES OF ARCHENG STUDIO PVT.LTD. UNAUTHORIZED USE OR REPRODUCTION OF PART OF THE DESIGN DRAWINGS OR CONCEPT TO USE IN OTHER PROJECTS OR SITES OTHER THAN SPECIFIED ON THIS DRAWING IS PROHIBITED

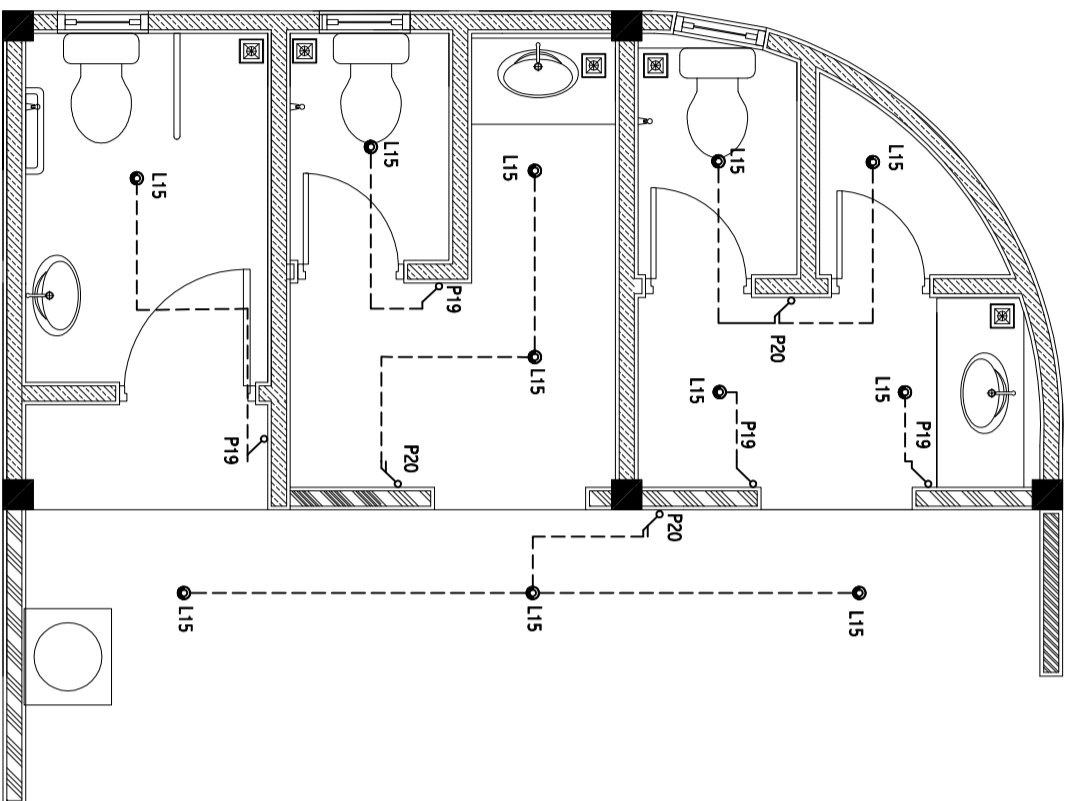


**TOILET BLOCK LIGHTING LAUOUT PLAN**  
SCALE 1:50

**LIGHTING LEGEND**

●	L15	1X16W ENERGY SAVING SLAB MOUNT WARM COMPACT FLUORESCENT LAMPS IN RECESSED DECORATIVE LUMINAIRE
---	-----	--

**SWITCHES LEGEND**

⏏	P19	1GANG 1 WAY SWITCH
⏏	P20	2GANG 1 WAY SWITCH

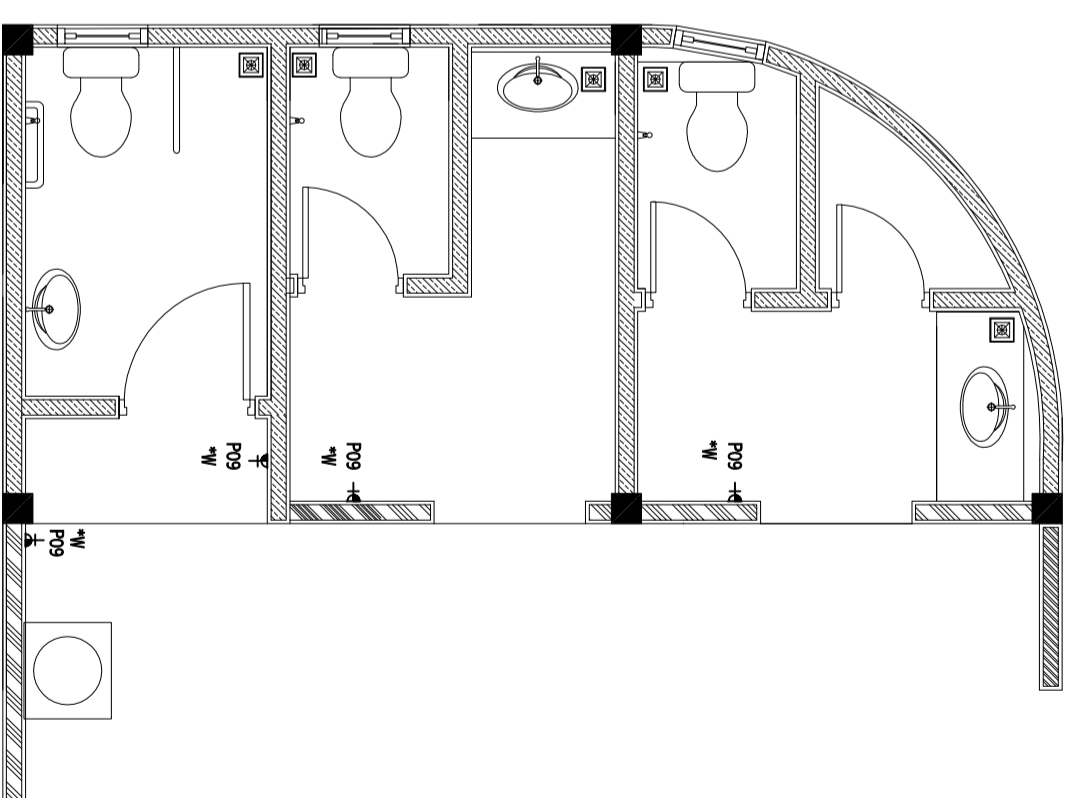

**TOILET BLOCK SOCKET LAUOUT PLAN**  
SCALE 1:50


**ELECTRICAL LEGEND**

SYMBOL	CODE	DESCRIPTION
P1-	P09	1 GANG/3A SOCKET OUTLET AT 1200mm ABOVE FINISHED FLOOR LEVEL


\*\* SOCKET INSTALLED INSIDE WEATHER PROOF COVER

CONTRACTORS MUST CHECK ALL DIMENSIONS ON SITE BEFORE ANY WORK OR SHOP DRAWINGS, FIGURED DIMENSIONS TO TAKE PRECEDENCE OVER SCALE READINGS

REVISION:	ARCHITECT:	PROJECT:	MALDIVES POLYTECHNIC, GA.VILINGILU CAMPUS
	ENGINEER:	LOCATION:	GA.VILINGILU
	ARCHITECTURAL CHECKER:	DRAWING TITLE:	AS GIVEN
	STRUCTURAL CHECKER:	CLIENT:	MINISTRY OF HIGHER EDUCATION
	DRAWN BY:	SCALE:	AS GIVEN
		DIMENSION:	MM
		DATE:	SEPTEMBER 2021
		DWG NO:	
		PROJECT NO.:	21-001

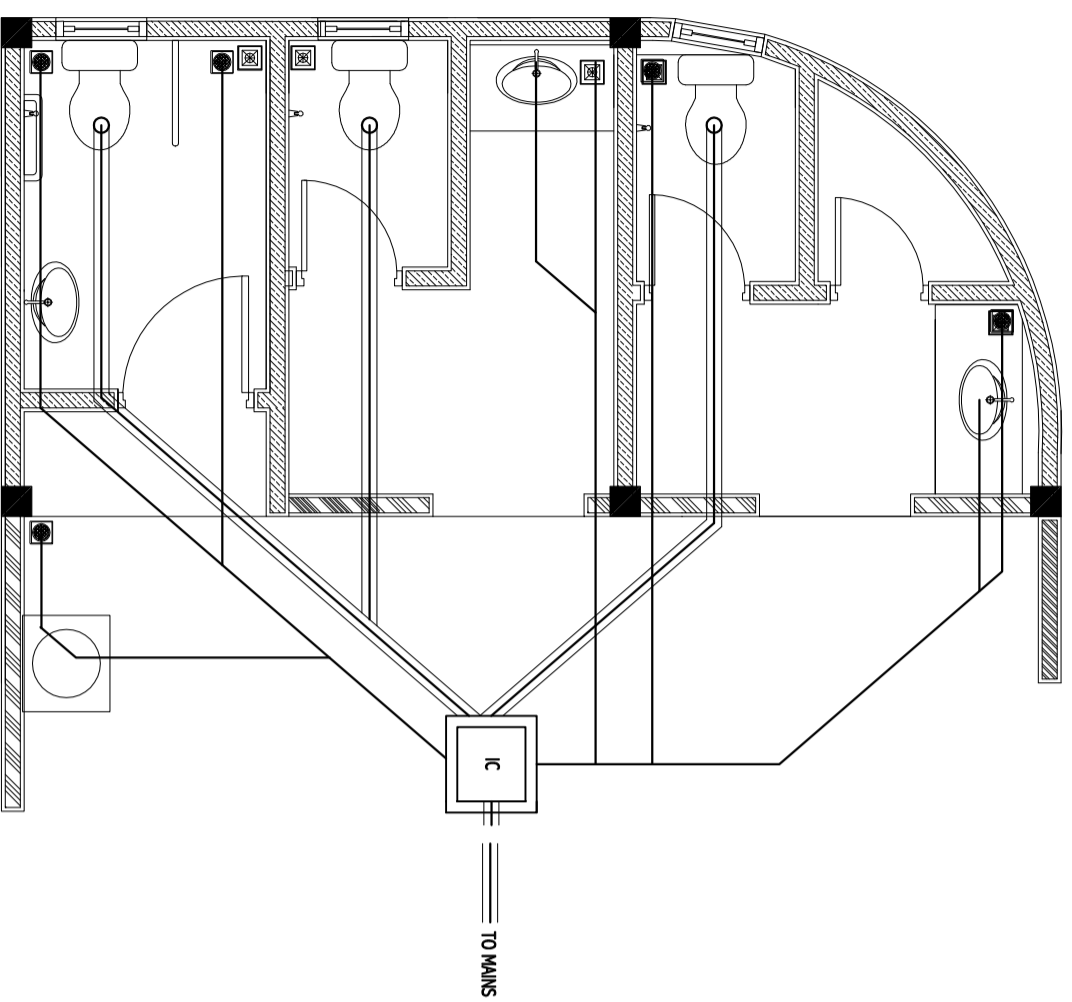

**TOILET BLOCK SEWAGE & WASTE DISPOSAL PLAN**  
SCALE 1:50

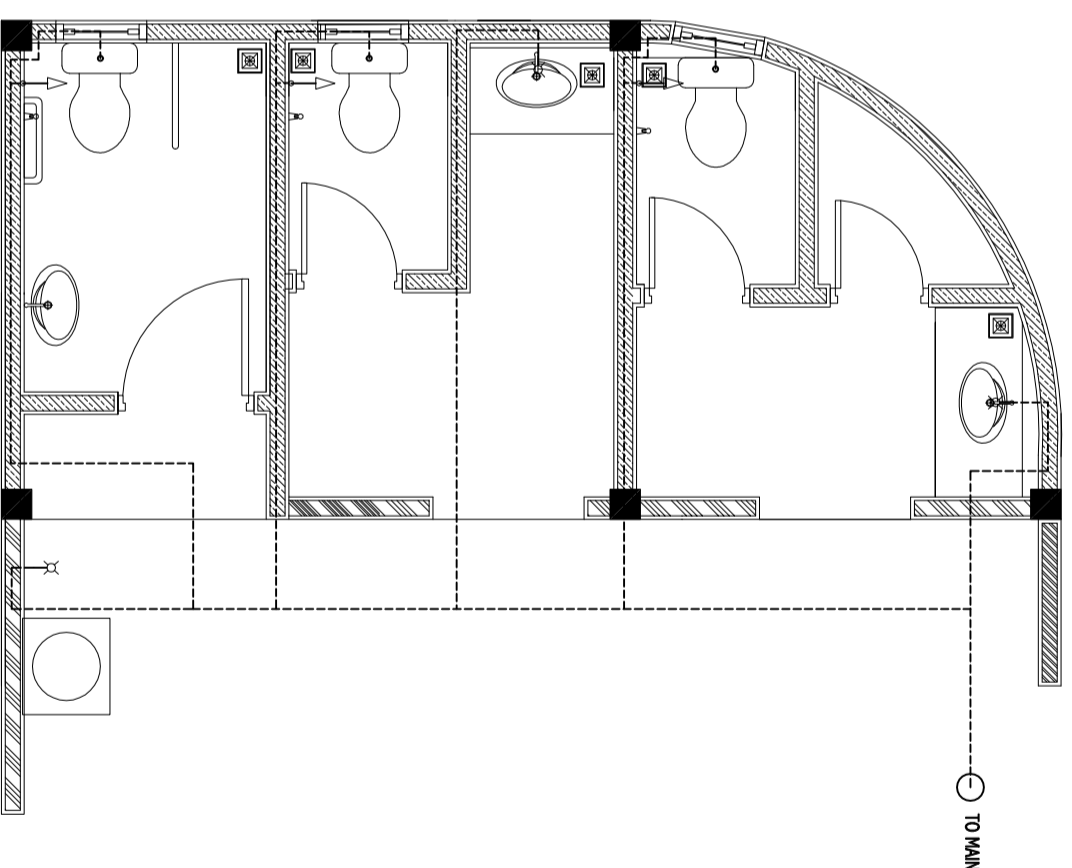

**TOILET BLOCK FRESH WATER SUPPLY PLAN**  
SCALE 1:50

**LEGEND**

SYMBOL	DESCRIPTION
	TAP
	MUSLIM SHOWER
	WATER SUPPLY (Ø12-Ø35)
	FLOOR DRAIN
	UPVC HIGH PRESSURE WASTE WATER PIPE (Ø75-Ø100)
	SEWAGE DISPOSAL (Ø100-Ø150)
	INSPECTION CHAMBER

CONTRACTORS MUST CHECK ALL DIMENSIONS ON SITE BEFORE ANY WORK OR SHOP DRAWINGS. FIGURED DIMENSIONS TO TAKE PRECEDENCE OVER SCALE READINGS.

REVISION:	ARCHITECT:	PROJECT:	DATE:
	ENGINEER: MARIYAM SUWAH	MALDIVES POLYTECHNIC, GAVILINGILU CAMPUS	SEPTEMBER 2021
	ARCHITECTURAL CHECKER:	LOCATION: GAVILINGILU	
	STRUCTURAL CHECKER:	DRAWING TITLE: AS GIVEN	
	DRAWN BY: HAWWA NISWA	CLIENT: MINISTRY OF HIGHER EDUCATION	
		SCALE: AS GIVEN	
		DIMENSION: MM	
		DATE: SEPTEMBER 2021	
		DWG NO.	<b>P-01</b>
		PROJECT NO.: 21-001	

CONCEPT AND DESIGN IN THIS DRAWING ARE THE PROPERTIES OF ARCHING STUDIO PVT LTD. UNAUTHORIZED USE OR REPRODUCTION OF PART OF THE DESIGN/DRAWINGS OR CONCEPT TO USE IN OTHER PROJECTS OR SITES OTHER THAN SPECIFIED ON THIS DRAWING IS PROHIBITED