



SITE PLANS - NEW DEPARTMENT OF PUBLIC SERVICES BUILDING



MEDWAY NEW DEPARTMENT OF
PUBLIC SERVICES FACILITY
PERSPECTIVE DRAWING

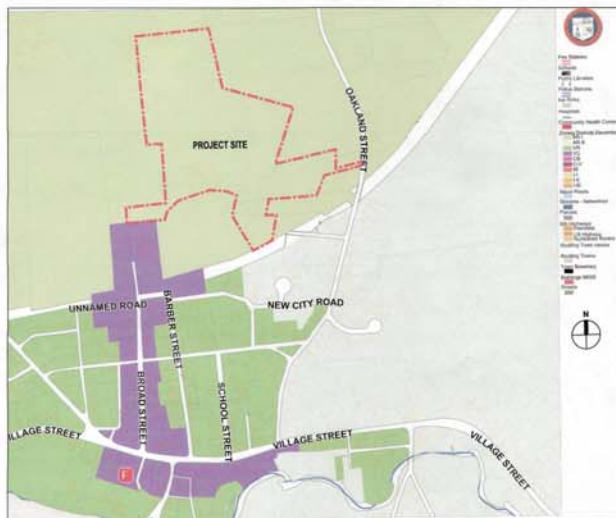

MEDWAY GIS MAP
SCALE: 1"=500'

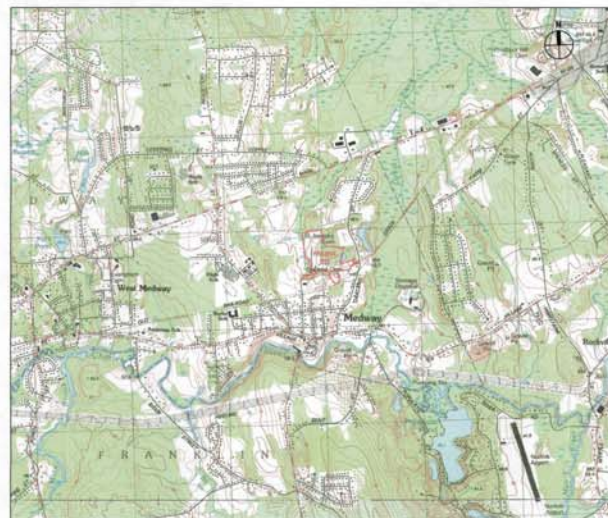

USGS MAP
SCALE: 1"=2,000'

ASSESSORS MAP PARCEL IDS: 50-002, 50-003, 50-003-001,
51-007 & 51-008

LIST OF APPROVED WAIVERS FROM THE SITE PLAN RULES AND REGULATIONS

- SECTION 204-3.A.7.a - TRAFFIC IMPACT ASSESSMENT
SECTION 204-3.A.7.b - ENVIRONMENTAL IMPACT
SECTION 204-3.A.7.c - COMMUNITY IMPACT
SECTION 204-3.A.7.d - PARKING IMPACT
SECTION 204-6.C.3 - EXISTING LANDSCAPE INVENTORY
SECTION 204-6.C.7 - LANDSCAPE ARCHITECT PLAN
SECTION 205-3.D. - PEDESTRIAN AND BICYCLE ACCESS
SECTION 205-9.C - AND CONNECTIONS
SECTION 205-9.D - INTERIOR LANDSCAPING - PARKING AREAS
SECTION 205-9.D - LANDSCAPE SCREENING



TOWN OF MEDWAY

NEW DPW FACILITY

OWNER:
TOWN OF MEDWAY
155 VILLAGE STREET
MEDWAY, MA 02053

ARCHITECT:
HELENE KARL
Architects, Inc.
61 Skyline Drive, Groton, Massachusetts 01450

CIVIL ENGINEER:
SYMES, MAIN & MURPHY ASSOCIATES
1000 MASSACHUSETTS AVENUE
CAMBRIDGE, MA 02138

STRUCTURAL ENGINEER:
SYMES, MAIN & MURPHY ASSOCIATES
1000 MASSACHUSETTS AVENUE
CAMBRIDGE, MA 02138

MECHANICAL ENGINEER:
SEAMAN ENGINEERING CORP.
22 WEST STREET, UNIT C
MILLBURY, MA 01527

ELECTRICAL ENGINEER:
JOHN J. MURPHY, JR. ELECTRICAL
CONSTRUCTION AND ENGINEERING, INC.
379 LIBERTY STREET
ROCKLAND, MA 02370

LIST OF DRAWINGS:

- C-001 COVER SHEET
C-100 SITE CONTEXT SHEET (BY SMMA)
C-101 EXISTING CONDITIONS PLAN I (BY SMMA)
C-102 EXISTING CONDITIONS PLAN II (BY SMMA)
C-111 SITE PREPARATION PLAN I (BY SMMA)
C-112 SITE PREPARATION PLAN II (BY SMMA)
C-121 LAYOUT & MATERIALS PLAN (BY SMMA)
C-131 GRADING AND UTILITIES PLAN I (BY SMMA)
C-132 GRADING AND UTILITIES PLAN II (BY SMMA)
C-151 PLANTING PLAN (BY HKA)
C-501 DETAILS I (BY SMMA)
C-502 DETAILS II (BY SMMA)
C-503 DETAILS III (BY SMMA)
C-504 DETAILS IV (BY SMMA)
C-505 DETAILS V (BY SMMA)
C-601 SEWER PROFILE I (BY SMMA)
C-602 SEWER PROFILE II (BY SMMA)
A-101 FIRST FLOOR PLAN (BY HKA)
A-102 SECOND FLOOR PLAN AND LOWER ROOF PLAN (BY HKA)
A-301 EXTERIOR ELEVATIONS SHEET 1 (BY HKA)
A-302 EXTERIOR ELEVATIONS SHEET 2 (BY HKA)
A-303 RENDERINGS (BY HKA)
SL-1 LIGHTING, LAYOUTS & SCHEDULE (SK & ASSOCIATES)

APPROVED BY:
TOWN OF MEDWAY PLANNING AND ECONOMIC
DEVELOPMENT BOARD

[Signature]
[Signature]
[Signature]

DATE: 3-26-2019

P:\2018\18043\18043-001 COVER SHEET.dwg 3/22/2019 1:14:18 PM

STAMP



DATE	DESCRIPTION
03/06/19	ISSUED FOR PRELIMINARY REVIEW
02/13/19	REVISED PER PRELIMINARY REVIEW COMMENTS
01/31/19	REVISED AND REISSUED FOR REVIEW
01/31/19	REVISED AND REISSUED FOR REVIEW
01/07/19	REVISED FOR DESIGN REVIEW
12/27/18	COMMITTEE REVIEW
12/20/18	ISSUED FOR SITE PLAN REVIEW

REV DATE DESCRIPTION

DATE AS NOTED

SCALE AS NOTED

DRAWN BY ACO

CHECKED BY PSG

PROJECT NO. 18043.00

BUILDING:

SHEET TITLE:

COVER SHEET

DRAWING NO.


C-001



APPROVED BY:
TOWN OF MEDWAY PLANNING AND
ECONOMIC DEVELOPMENT BOARD
[Signature]
[Signature]
DATE: 3-26-2019



LEGEND	
AR-I	AGRICULTURAL RESIDENTIAL I
AR-II	AGRICULTURAL RESIDENTIAL II
VC	VILLAGE COMMERCIAL
VR	VILLAGE RESIDENTIAL
2,000 RADIUS	2,000 RADIUS
ZONING BOUNDS	ZONING BOUNDS
SCENIC ROAD	SCENIC ROAD
PROPERTY LINE	PROPERTY LINE

 

TOWN OF MEDWAY **NEW DPW FACILITY**

OWNER:
TOWN OF MEDWAY
155 VILLAGE STREET
MEDWAY, MA 02053

ARCHITECT:
HELENE • KARL
Architects, Inc.
61 Skyline Drive, Groton, Massachusetts 01450

CIVIL ENGINEER:
SYMES, MANN & McKEE ASSOCIATES
1000 MASSACHUSETTS AVENUE
CAMBRIDGE, MA 02138

STRUCTURAL ENGINEER:
SYMES, MANN & McKEE ASSOCIATES
1000 MASSACHUSETTS AVENUE
CAMBRIDGE, MA 02138

MECHANICAL ENGINEER:
SEAMAN ENGINEERING CORP.
22 WEST STREET, UNIT C
MILBURY, MA 01527

ELECTRICAL ENGINEER:
JOHN J. MURPHY, JR. ELECTRICAL
CONSTRUCTION AND ENGINEERING, INC.
379 LIBERTY STREET
ROCKLAND, MA 02370

STAMP



03/06/19	ISSUED FOR PRELIMINARY BOARD ENFORCEMENT
02/13/19	REVISED FOR PEER REVIEW COMMENTS REQUESTED TO P.C.
01/31/19	AMENDED AND REQUESTED FOR REVIEW
01/31/19	REVISED AND REQUESTED FOR REVIEW
01/07/19	ISSUED FOR DESIGN REVIEW COMMITTEE REVIEW
12/27/18	ISSUED FOR NOTICE OF INTENT
12/20/18	ISSUED FOR SITE PLAN REVIEW

REV	DATE	DESCRIPTION
-----	------	-------------

DATE: _____
SCALE: 1" = 300'
DRAWN BY: ACO
CHECKED BY: PSG
PROJECT NO.: 18043.00

BUILDING: _____
SHEET TITLE:
**SITE
CONTEXT
SHEET**

DRAWING NO.:
C-100



ARCHITECT:
 **HELENE • KARL**
Architects, Inc.
61 Skyfitch Drive, Groton, Massachusetts 01450

MECHANICAL ENGINEER:
SEAMAN ENGINEERING CORP.
22 WEST STREET, UNIT C
MILLBURY, MA 01527


ELECTRICAL ENGINEER:
JOHN J. MURPHY, JR. ELECTRICAL
CONSTRUCTION AND ENGINEERING, INC.
379 LIBERTY STREET
ROCKLAND, MA 02370


SEAL OF THE COMMONWEALTH OF MASSACHUSETTS
 PETER D. ILICH
 CIVIL
 No. 41014
 REGISTERED
 PROFESSIONAL ENGINEER

DATE	
SCALE	1" = 40'
DRAWN BY	ACO
CHECKED BY	PSG
PROJECT NO.	18043.00

EXISTING
CONDITIONS
PLAN I

C-101

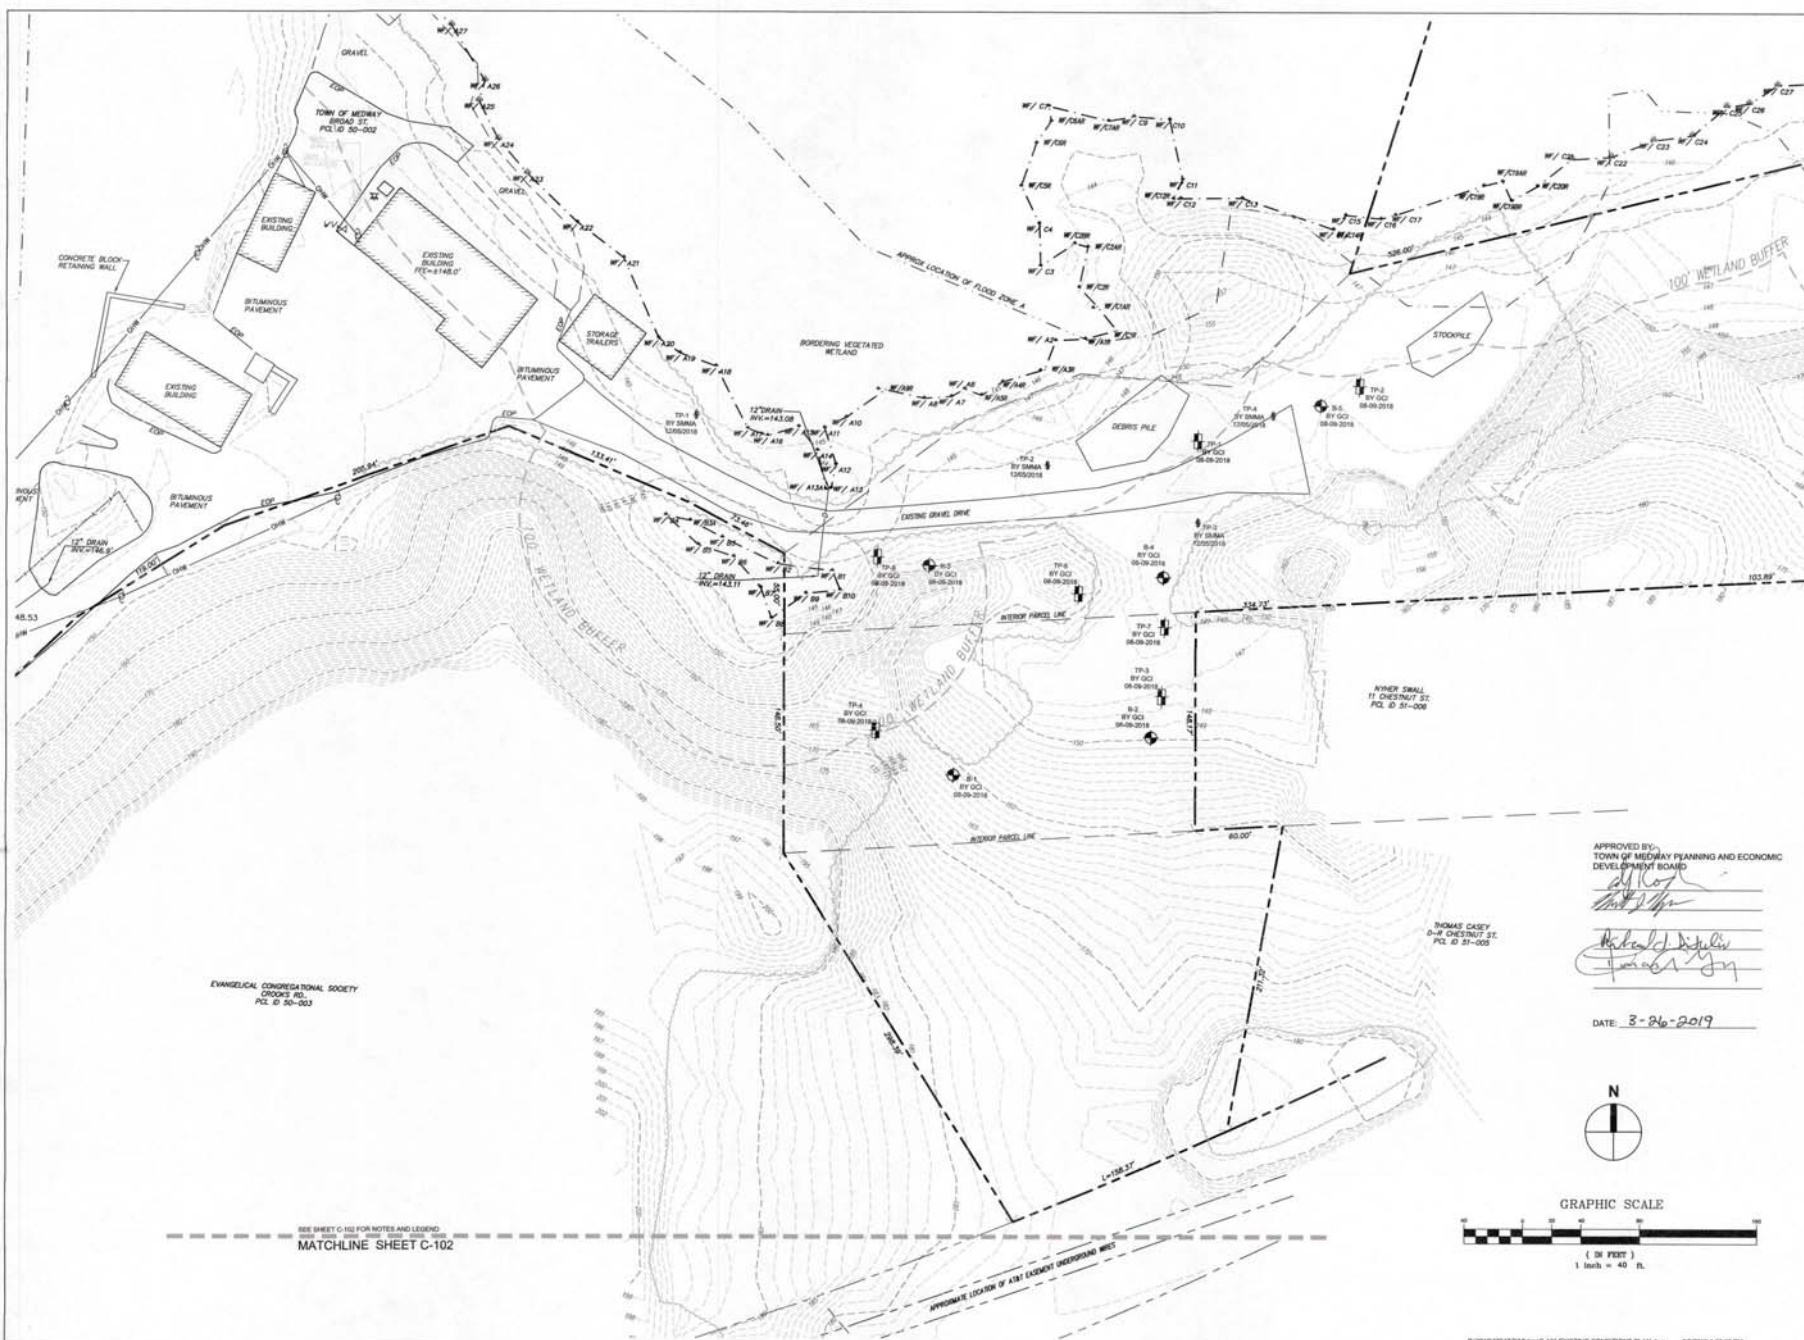

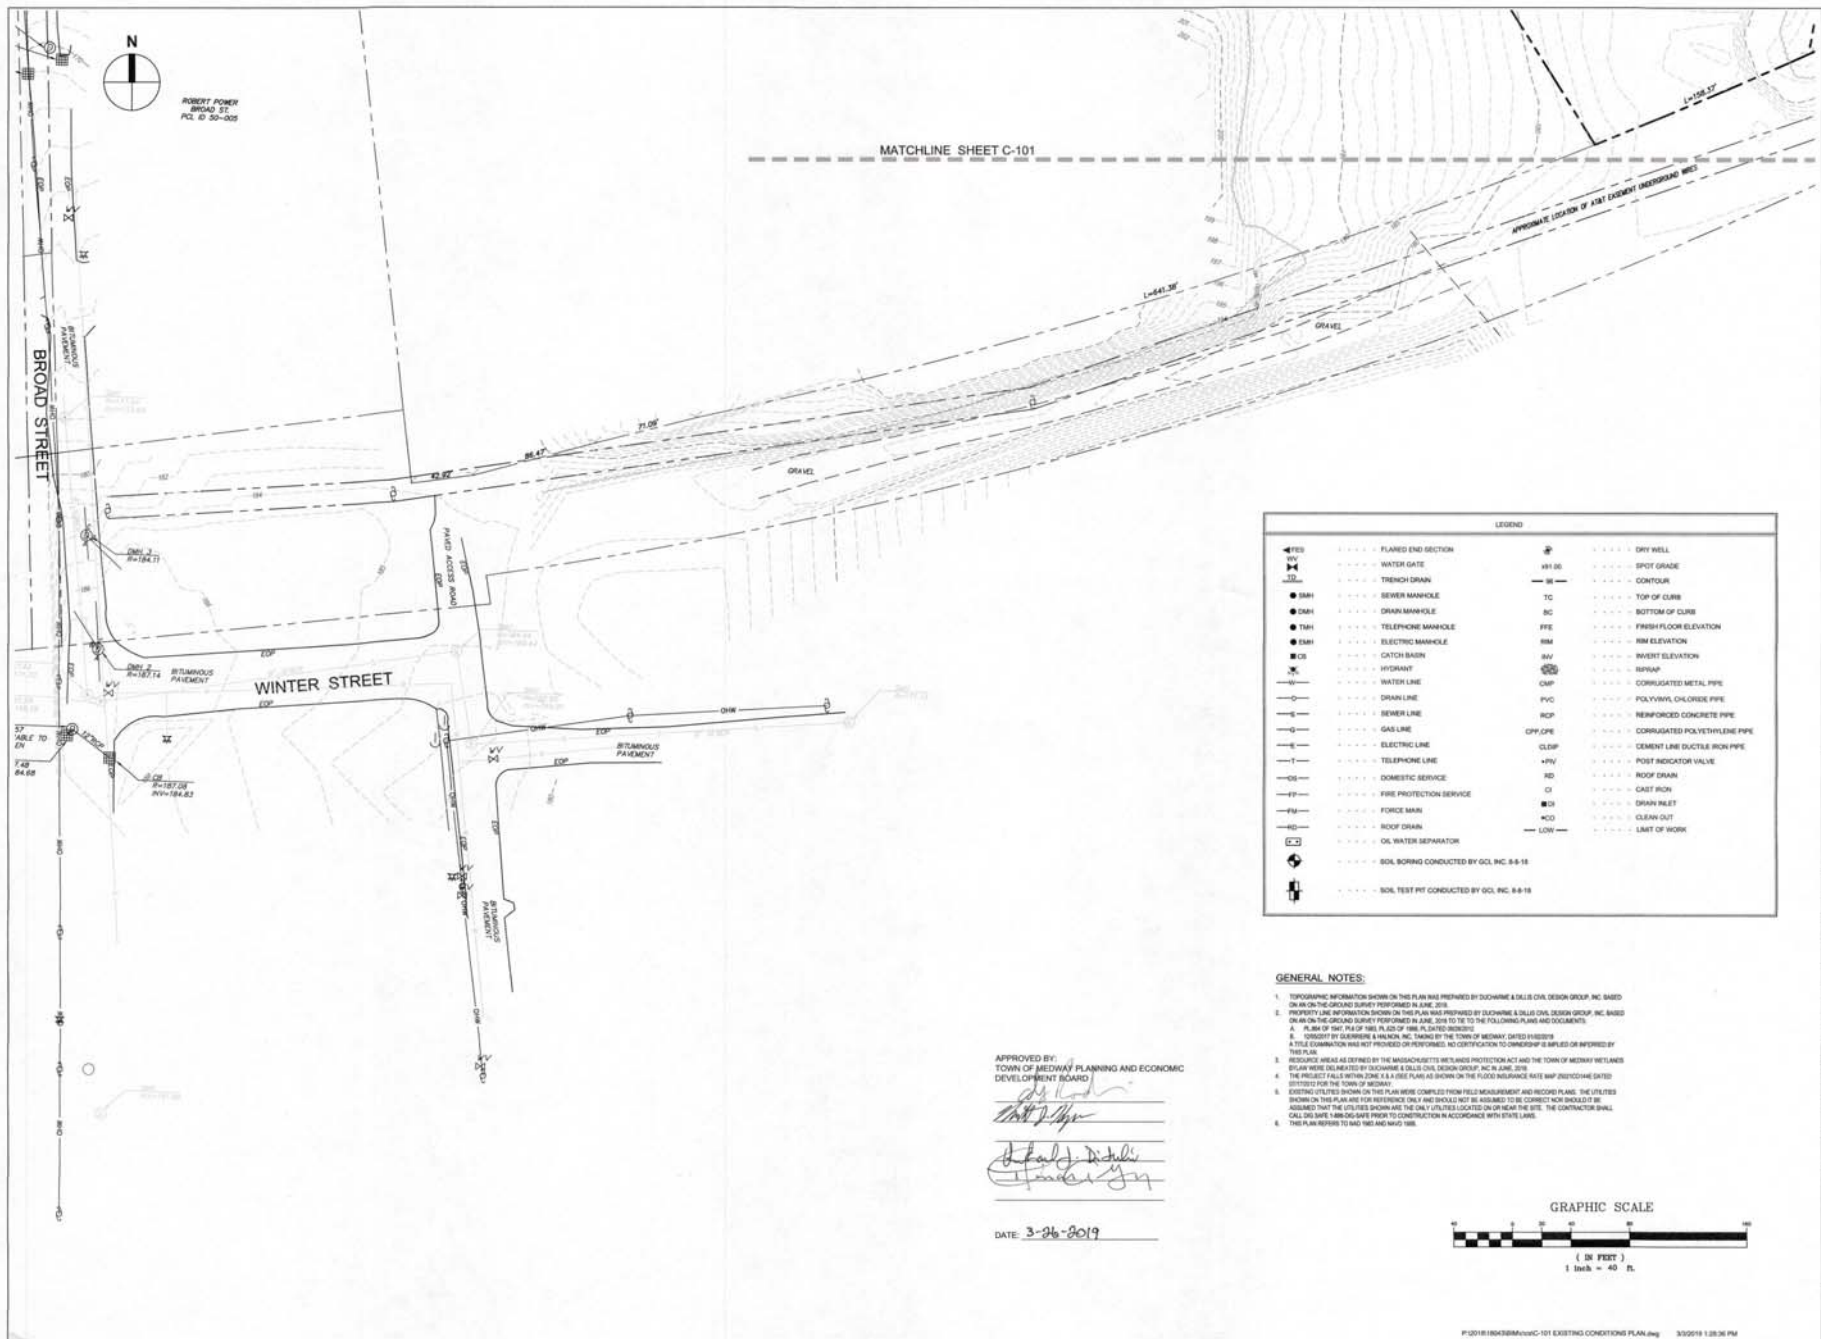

TOWN OF MEDWAY

NEW DPW FACILITY

OWNER:
TOWN OF MEDWAY
155 VILLAGE STREET
MEDWAY, MA 02053

ARCHITECT:
HELENE KARL
Architects, Inc.
61 Skylands Drive, Green, Massachusetts 01450

CIVIL ENGINEER:
SYMME, MAIN & McKEE ASSOCIATES
1000 MASSACHUSETTS AVENUE
CAMBRIDGE, MA 02138

STRUCTURAL ENGINEER:
SYMME, MAIN & McKEE ASSOCIATES
1000 MASSACHUSETTS AVENUE
CAMBRIDGE, MA 02138

MECHANICAL ENGINEER:
SEAMAN ENGINEERING CORP.
22 WEST STREET, UNIT C
MILBURY, MA 01527

ELECTRICAL ENGINEER:
JOHN J. MURPHY, JR. ELECTRICAL
CONSTRUCTION AND ENGINEERING, INC.
379 LIBERTY STREET
ROCKLAND, MA 02370

STAMP



03/06/19	ISSUED FOR PRELIMINARY BOARD REVIEW
02/13/19	REVISED PER PRELIMINARY REVIEW COMMENTS
01/31/19	REVISED AND REISSUED TO C.C.
01/31/19	REVISED AND REISSUED FOR AMENDMENT NO. 1
01/31/19	REVISED AND REISSUED FOR SITE PLAN REVIEW
01/07/19	ISSUED FOR DESIGN REVIEW COMMITTEE REVIEW
12/27/18	ISSUED FOR NOTICE OF INTENT
12/20/18	ISSUED FOR SITE PLAN REVIEW


REV	DATE	DESCRIPTION
1	03/06/19	ISSUED FOR PRELIMINARY BOARD REVIEW

BUILDING:
SHEET TITLE:

EXISTING CONDITIONS
PLAN II

DRAWING NO.

C-102

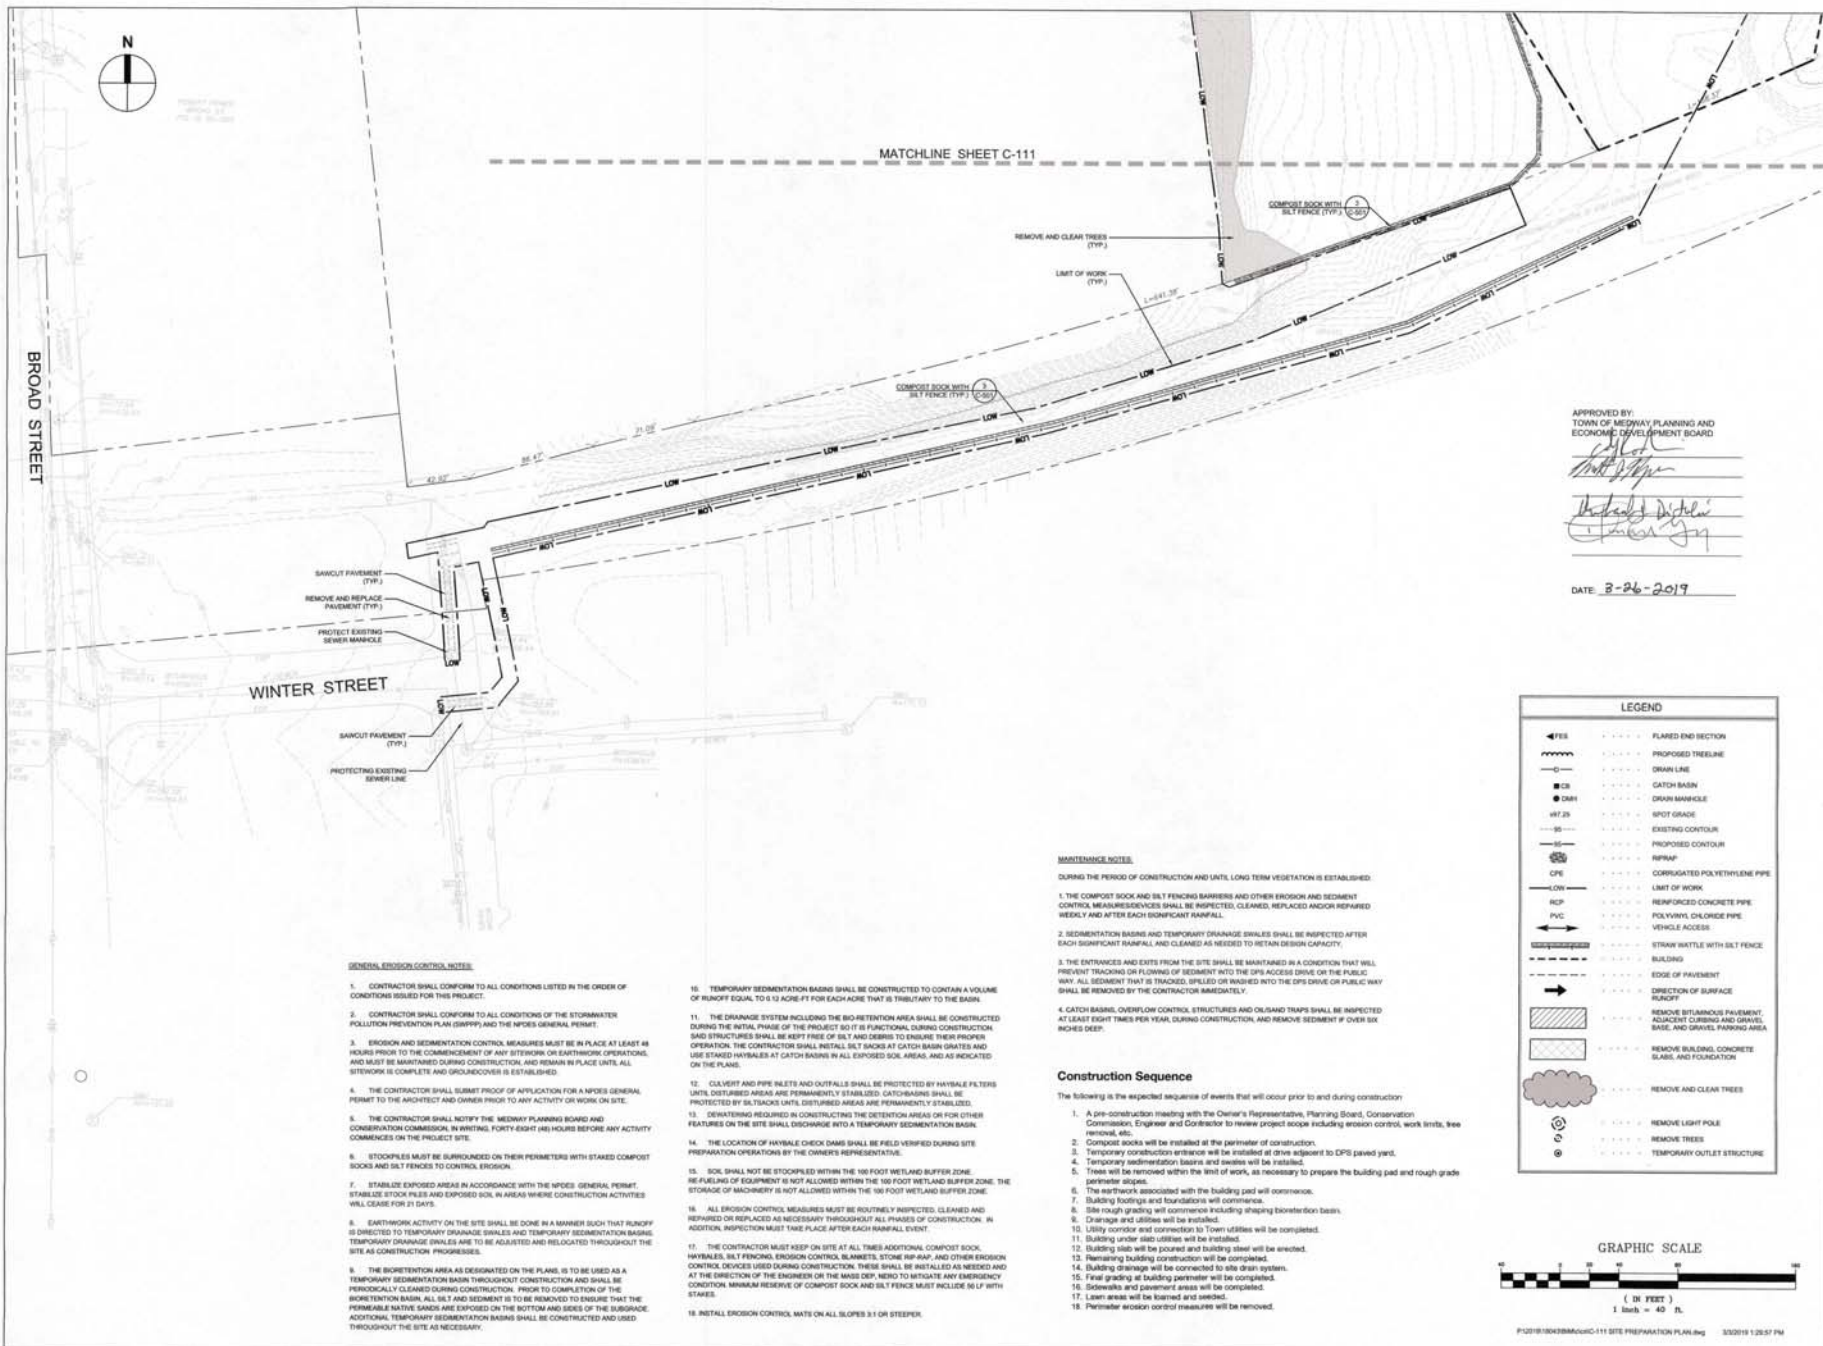

TOWN OF MEDWAY

NEW DPW FACILITY

OWNER:

TOWN OF MEDWAY
155 VILLAGE STREET
MEDWAY, MA 02053

ARCHITECT:

HELENE · KARL
Architects, Inc.
1/1 Skyline Drive, Groton, Massachusetts 01400

CIVIL ENGINEER:

SYMMES, MAIN & MCKEE ASSOCIATES
1000 MASSACHUSETTS AVENUE
CAMBRIDGE, MA 02138

STRUCTURAL ENGINEER:

SYMMES, MAIN & MCKEE ASSOCIATES
1000 MASSACHUSETTS AVENUE
CAMBRIDGE, MA 02138

MECHANICAL ENGINEER:

SEAMAN ENGINEERING CORP.
22 WEST STREET, UNIT C
MILLBURY, MA 01502

ELECTRICAL ENGINEER:

JOHN J. MURPHY, JR., ELECTRICAL
CONSTRUCTION AND ENGINEERING, INC.
379 LIBERTY STREET
ROCKLAND, MA 02370

STAMP



REV	DATE	DESCRIPTION
03/06/19		ISSUED FOR PERMITS BOARD
02/13/19		REVISED PER PERMITS BOARD COMMENTS
01/31/19		REVISED AND REISSUED FOR PERMITS BOARD
01/31/19		REVISED AND REISSUED FOR PERMITS BOARD
01/07/19		REVISED FOR DESIGN REVIEW
12/27/18		REVISED FOR DESIGN REVIEW
12/20/18		REVISED FOR SITE PLAN REVIEW

DATE	
SCALE	1" = 40'
DRAWN BY	ACO
CHECKED BY	PSG
PROJECT NO.	18043.00

BUILDING:

SHEET TITLE:

EROSION AND SEDIMENT CONTROL PLAN II

DRAWING NO.

C-112



TOWN OF MEDWAY

NEW DPW FACILITY

OWNER:

TOWN OF MEDWAY
155 VILLAGE STREET
MEDWAY, MA 02053

ARCHITECT:

HELENE KARL
Architects, Inc.
61 Skyline Drive, Canton, Massachusetts 01910

CIVIL ENGINEER:

SYMMES, MAIN & McKEE ASSOCIATES
1000 MASSACHUSETTS AVENUE
CAMBRIDGE, MA 02138

STRUCTURAL ENGINEER:

SYMMES, MAIN & McKEE ASSOCIATES
1000 MASSACHUSETTS AVENUE
CAMBRIDGE, MA 02138

MECHANICAL ENGINEER:

SEAMAN ENGINEERING CORP.
22 WEST STREET, UNIT C
MILLBURY, MA 01527

ELECTRICAL ENGINEER:

JOHN J. MURPHY, JR. ELECTRICAL
CONSTRUCTION AND ENGINEERING, INC.
379 LIBERTY STREET
ROCKLAND, MA 02370

STAMP



 
APPROVED BY:
TOWN OF MEDWAY PLANNING AND
ECONOMIC DEVELOPMENT BOARD

[Signature]
[Signature]
[Signature]

DATE: 3-26-2019



GRAPHIC SCALE



P:\2018\18043\BROWSE\131 GRADING & UTILITY PLAN.dwg 3/23/2019 1:30:03 PM

03/06/19	ISSUED FOR PERM BOARD
02/13/19	INFORMED PER PERM REVIEW
01/31/19	COMMENTS RECEIVED TO C.C.
01/31/19	REVISED AND RESUBMITTED FOR
01/31/19	AMENDED NOT
01/07/19	REVISED AND RESUBMITTED FOR
12/27/18	COMMITTEE REVIEW
12/27/18	ISSUED FOR NOTICE OF
12/27/18	INTENT
12/27/18	ISSUED FOR SITE PLAN
12/27/18	REVIEW

REV	DATE	DESCRIPTION
-----	------	-------------

DATE	SCALE
------	-------

	1" = 40'
--	----------

DRAWN BY	ACO
----------	-----

CHECKED BY	PSG
------------	-----

PROJECT NO.	18043.00
-------------	----------


BUILDING:

SHEET TITLE:

GRADING &
UTILITY
PLAN I

DRAWING NO.

C-131

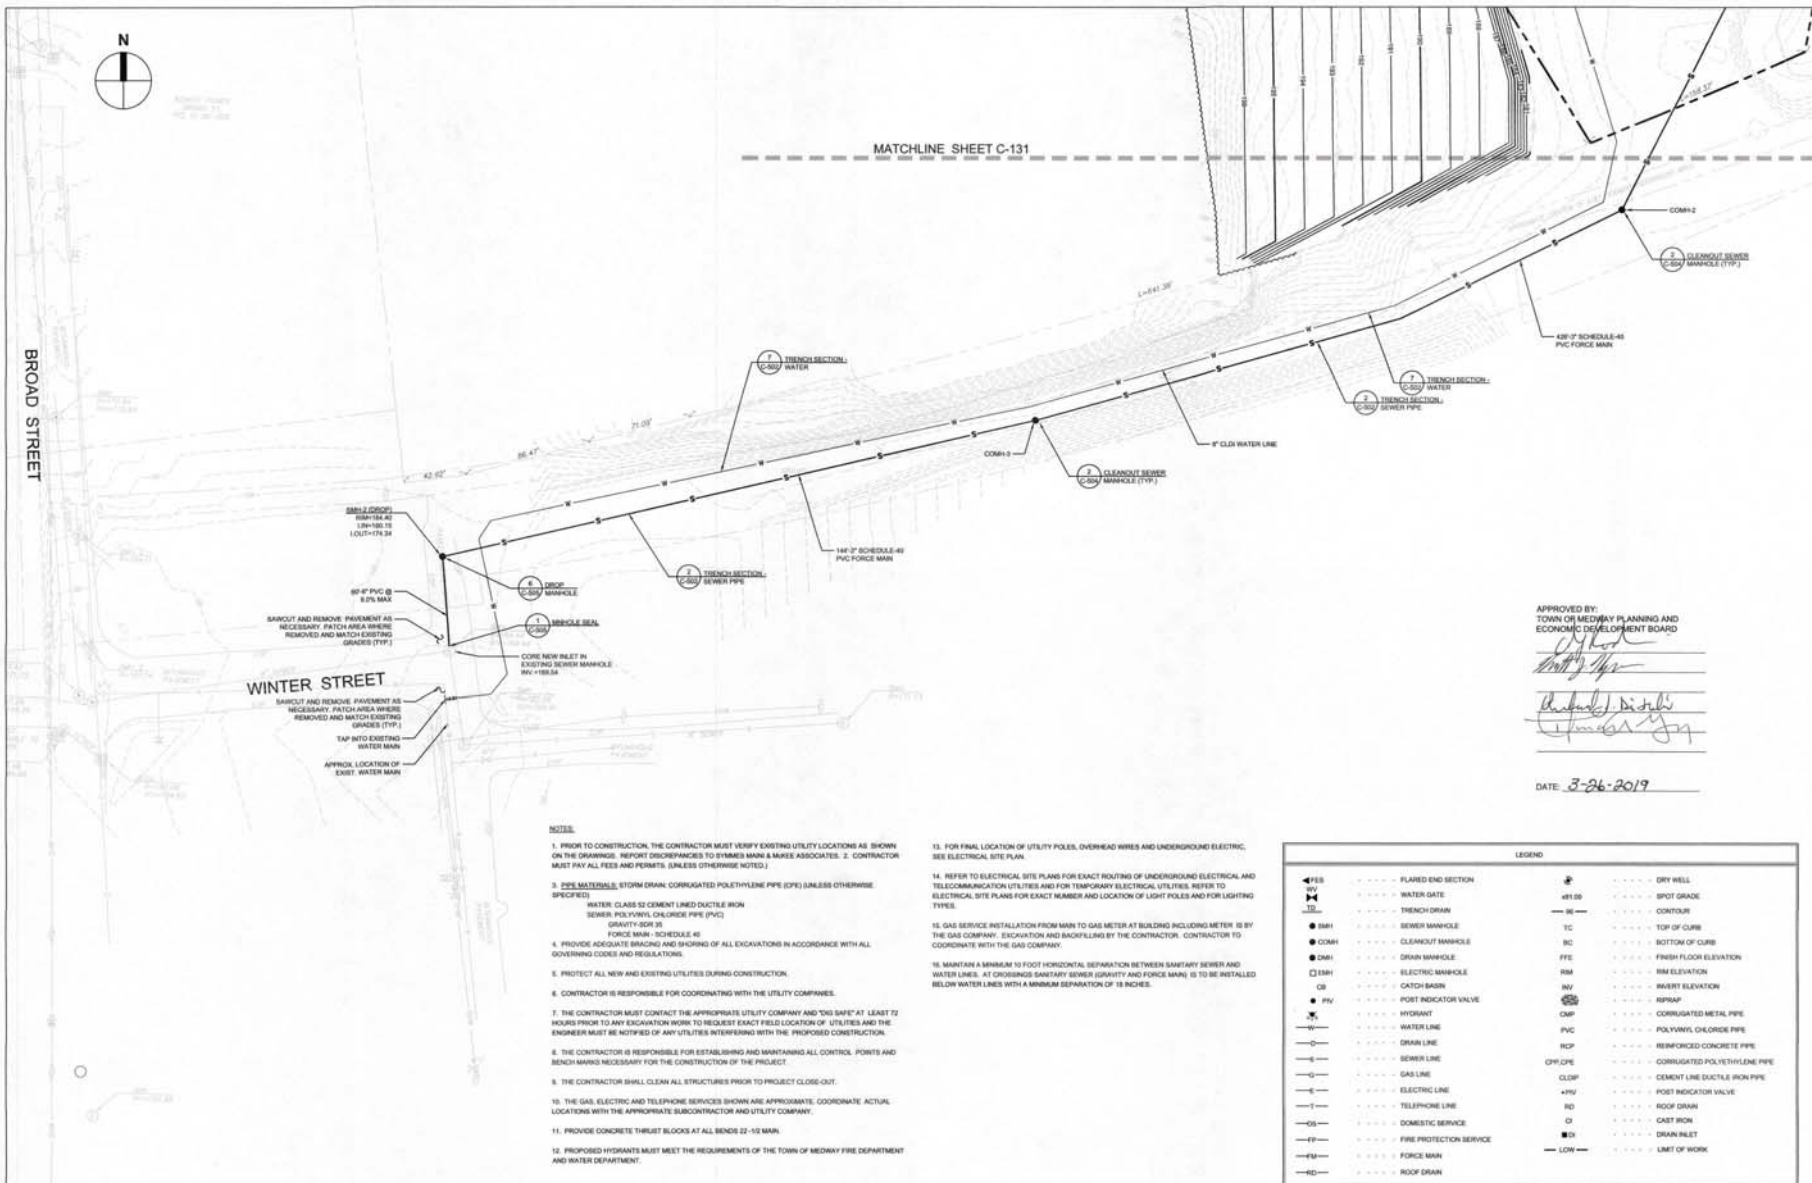

APPROVED BY:
TOWN OF MEDWAY PLANNING AND
ECONOMIC DEVELOPMENT BOARD

[Signature]
[Signature]
[Signature]


DATE: 3-26-2019

NOTES

1. PRIOR TO CONSTRUCTION, THE CONTRACTOR MUST VERIFY EXISTING UTILITY LOCATIONS AS SHOWN ON THE DRAWINGS. REPORT DISCREPANCIES TO SYMMES, MAINI & McKEE ASSOCIATES. 2. CONTRACTOR MUST PAY ALL FEES AND PERMITS, UNLESS OTHERWISE NOTED.
3. **Pipe Materials:** STORM DRAIN: CORRUGATED POLYETHYLENE PIPE (CPE) UNLESS OTHERWISE SPECIFIED.
WATER: CLASS 52 CEMENT LINED DUCTILE IRON
SEWER: POLYVINYL CHLORIDE PIPE (PVC)
GRAVITY: SDR 35
FORCE MAIN: SCHEDULE 40
4. PROVIDE ADEQUATE BRACING AND SHORING OF ALL EXCAVATIONS IN ACCORDANCE WITH ALL GOVERNING CODES AND REGULATIONS.
5. PROTECT ALL NEW AND EXISTING UTILITIES DURING CONSTRUCTION.
6. CONTRACTOR IS RESPONSIBLE FOR COORDINATING WITH THE UTILITY COMPANIES.
7. THE CONTRACTOR MUST CONTACT THE APPROPRIATE UTILITY COMPANY AND "DIG DATE" AT LEAST 72 HOURS PRIOR TO ANY EXCAVATION WORK TO REQUEST EXACT FIELD LOCATION OF UTILITIES AND THE ENGINEER MUST BE NOTIFIED OF ANY UTILITIES INTERFERING WITH THE PROPOSED CONSTRUCTION.
8. THE CONTRACTOR IS RESPONSIBLE FOR ESTABLISHING AND MAINTAINING ALL CONTROL POINTS AND BENCH MARKS NECESSARY FOR THE CONSTRUCTION OF THE PROJECT.
9. THE CONTRACTOR SHALL CLEAN ALL STRUCTURES PRIOR TO PROJECT CLOSE-OUT.
10. THE GAS, ELECTRIC AND TELEPHONE SERVICES SHOWN ARE APPROXIMATE. COORDINATE ACTUAL LOCATIONS WITH THE APPROPRIATE SUBCONTRACTOR AND UTILITY COMPANY.
11. PROVIDE CONCRETE THRUST BLOCKS AT ALL BENDS 22-10 MAIN.
12. PROPOSED HYDRANTS MUST MEET THE REQUIREMENTS OF THE TOWN OF MEDWAY FIRE DEPARTMENT AND WATER DEPARTMENT.

13. FOR FINAL LOCATION OF UTILITY POLES, OVERHEAD WIRES AND UNDERGROUND ELECTRICAL, SEE ELECTRICAL SITE PLAN.
14. REFER TO ELECTRICAL SITE PLANS FOR EXACT ROUTING OF UNDERGROUND ELECTRICAL AND TELECOMMUNICATION UTILITIES AND FOR TEMPORARY ELECTRICAL UTILITIES. REFER TO ELECTRICAL SITE PLANS FOR EXACT NUMBER AND LOCATION OF LIGHT POLES AND FOR LIGHTING TYPES.
15. GAS SERVICE INSTALLATION FROM MAIN TO GAS METER AT BUILDING INCLUDING METER IS BY THE GAS COMPANY. EXCAVATION AND BACKFILLING BY THE CONTRACTOR. CONTRACTOR TO COORDINATE WITH THE GAS COMPANY.
16. MAINTAIN A MINIMUM 10 FOOT HORIZONTAL SEPARATION BETWEEN SANITARY SEWER AND WATER LINES. AT CROSSINGS SANITARY SEWER (GRAVITY AND FORCE MAIN) IS TO BE INSTALLED BELOW WATER LINES WITH A MINIMUM SEPARATION OF 18 INCHES.

LEGEND	
FLARED END SECTION	DRY WELL
WATER GATE	SPOT GRADE
TRENCH DRAIN	CONTOUR
SEWER MANHOLE	TOP OF CURB
CLEANOUT MANHOLE	BOTTOM OF CURB
DRAIN MANHOLE	FINISH FLOOR ELEVATION
ELECTRIC MANHOLE	RIM ELEVATION
CATCH BASIN	INVERT ELEVATION
PORT INDICATOR VALVE	REPAIR
HYDROVENT	CORRUGATED METAL PIPE
WATER LINE	POLYVINYL CHLORIDE PIPE
DRAIN LINE	REINFORCED CONCRETE PIPE
SEWER LINE	CORRUGATED POLYETHYLENE PIPE
GAS LINE	CEMENT LINE DUCTILE IRON PIPE
ELECTRIC LINE	PORT INDICATOR VALVE
TELEPHONE LINE	ROOF DRAIN
DOMESTIC SERVICE	CAST IRON
FIRE PROTECTION SERVICE	DRAIN INLET
FORCE MAIN	LIMIT OF WORK
ROOF DRAIN	

 

P:\2018\18043B\18043B-131 GRADING & UTILITY PLAN.dwg 3/26/19 1:36:15 PM



TOWN OF MEDWAY NEW DPW FACILITY

OWNER:
TOWN OF MEDWAY
155 VILLAGE STREET
MEDWAY, MA 02053

 
ARCHITECT:
HELENE • KARL
Architects, Inc.
61 Skyline Drive, Canton, Massachusetts 01450

CIVIL ENGINEER:
SYMMES, MAINI & McKEE ASSOCIATES
1000 MASSACHUSETTS AVENUE
CAMBRIDGE, MA 02138

STRUCTURAL ENGINEER:
SYMMES, MAINI & McKEE ASSOCIATES
1000 MASSACHUSETTS AVENUE
CAMBRIDGE, MA 02138

MECHANICAL ENGINEER:
SEAMAN ENGINEERING CORP.
22 WEST STREET, UNIT C
MILLBURY, MA 01527

ELECTRICAL ENGINEER:
JOHN J. MURPHY, JR. ELECTRICAL
CONSTRUCTION AND ENGINEERING, INC.
378 LIBERTY STREET
ROCKLAND, MA 02370




REV	DATE	DESCRIPTION
03/06/19	ISSUED FOR PERMITS BOARD	
02/13/19	REVISION PER PERMITS BOARD	
01/31/19	COMMENTS REVISION TO C.G.	
01/31/19	REVISED AND REISSUED FOR	
01/31/19	AMENDED FOR	
01/07/19	REVISION FOR DESIGN REVIEW	
12/27/18	COMPLETED DESIGN	
12/20/18	ISSUED FOR PERMITS BOARD	


DATE	SCALE	DRAWN BY	CHECKED BY	PROJECT NO.
03/06/19	1" = 40'	ACO	PSG	18043.00

BUILDING:
SHEET TITLE:
**GRADING &
UTILITY
PLAN II**


DRAWING NO.
C-132

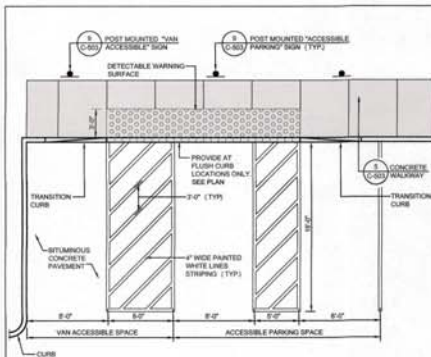


8 ACCESSIBLE PARKING SPACES
N.T.S.

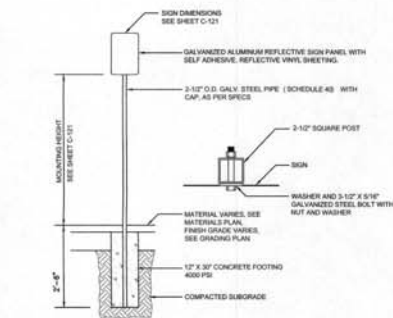


9 PARKING SIGN
N.T.S.

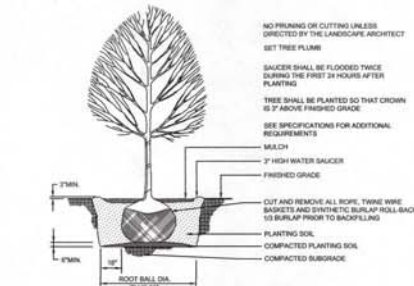


10 DECIDUOUS TREE
N.T.S.

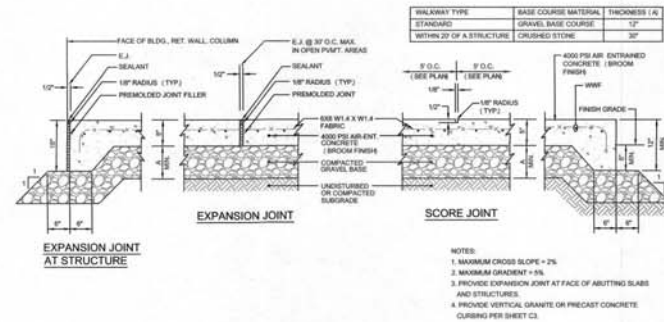


5 CONCRETE WALKWAY
N.T.S.

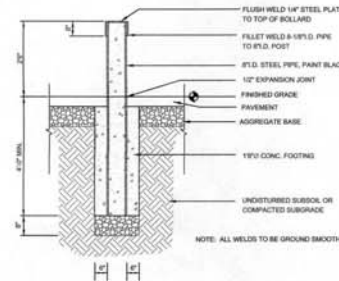


6 STEEL BOLLARD
N.T.S.

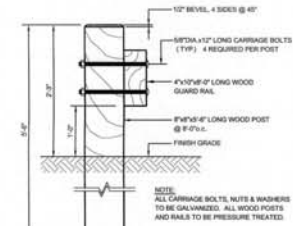


7 WOOD GUARDRAIL
N.T.S.

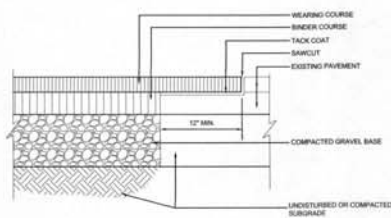


1 BITUMINOUS CONCRETE AT EXISTING PAVEMENT
N.T.S.

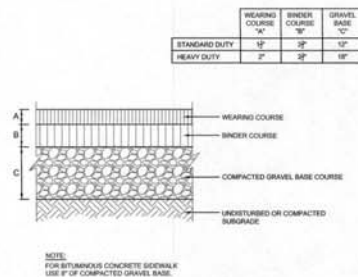

2 BITUMINOUS CONCRETE PAVEMENT
N.T.S.

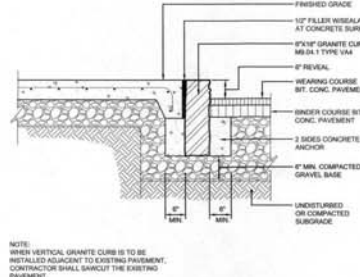

3 VERTICAL GRANITE CURB
N.T.S.

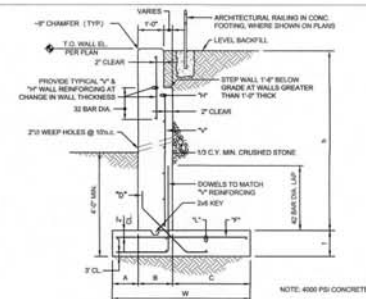

4 CONCRETE RETAINING WALL
N.T.S.

RETAINING WALL TYPE "A"									
h	A	B	C	W	I	V	H	F	L
8' to 12'	1'-0"	1'-0"	2'-0"	4'-0"	1'-0"	1'-0"	1'-0"	1'-0"	1'-0"
12' to 16'	1'-0"	1'-0"	2'-0"	4'-0"	1'-0"	1'-0"	1'-0"	1'-0"	1'-0"

NOTE: IN-BETWEEN DIMENSIONS MUST ALWAYS BE ROUNDED UP.



TOWN OF
MEDWAY

NEW DPW FACILITY

OWNER:
TOWN OF MEDWAY
100 MASSACHUSETTS AVENUE
MEDWAY, MA 02053

ARCHITECT:
HELENE KARL
Architects, Inc.
41 Skyline Drive, Canton, Massachusetts 01910

CIVIL ENGINEER:
SYMES, MAIN & MCKEE ASSOCIATES
1000 MASSACHUSETTS AVENUE
CAMBRIDGE, MA 02138

STRUCTURAL ENGINEER:
SYMES, MAIN & MCKEE ASSOCIATES
1000 MASSACHUSETTS AVENUE
CAMBRIDGE, MA 02138

MECHANICAL ENGINEER:
SEAMAN ENGINEERING CORP.
22 WEST STREET, UNIT C
MILBURY, MA 01527

ELECTRICAL ENGINEER:
JOHN J. MURPHY, JR. ELECTRICAL
CONSTRUCTION AND ENGINEERING, INC.
379 LIBERTY STREET
ROCKLAND, MA 02370



STAMP


REV	DATE	DESCRIPTION
03/06/19		ISSUED FOR PERMITS BOARD
02/13/19		REVISED PER PERMITS BOARD
01/31/19		REVISED PER PERMITS BOARD
01/31/19		REVISED PER PERMITS BOARD
01/07/19		REVISED PER PERMITS BOARD
12/27/18		REVISED PER PERMITS BOARD
12/20/18		REVISED PER PERMITS BOARD

DATE: NTS
SCALE: ACO
DRAWN BY: PSG
CHECKED BY: PSG
PROJECT NO. 18043.00


BUILDING: NTS

SHEET TITLE: DETAILS III


DRAWING NO. C-503

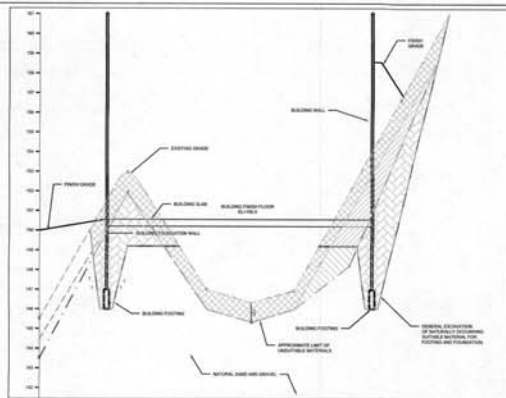


SCALES: HORIZONTAL 1"=30'
VERTICAL 1"=3'

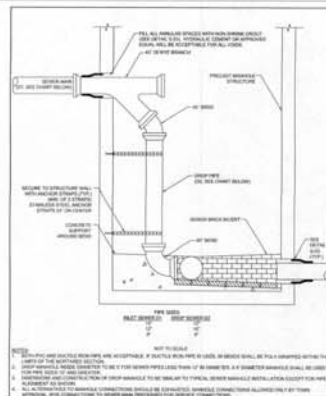

6 SEWER DROP MANHOLE (INSIDE)
N.T.S.

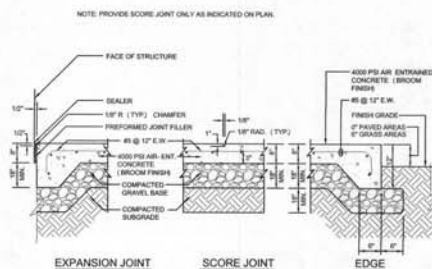

2 CONCRETE EQUIPMENT PAD
N.T.S.

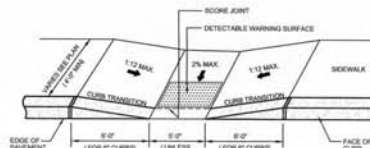

4 ACCESSIBLE CURB CUT (TYPE 2)

OWNER:
TOWN OF MEDWAY
155 VILLAGE STREET
MEDWAY, MA 02053

ARCHITECT:
 **HELENE • KARL**
Architects, Inc.
63 Norfolk Drive, Groton, Massachusetts 01454

CIVIL ENGINEER:
 SYMMES, MAIN & McKEE ASSOCIATES
 1000 MASSACHUSETTS AVENUE
 CAMBRIDGE, MA 02138

STRUCTURAL ENGINEER:
SYMMES, MAIN & MCKEE ASSOCIATES
1000 MASSACHUSETTS AVENUE
CAMBRIDGE, MA 02138

MECHANICAL ENGINEER:
SEAMAN ENGINEERING CORP.
22 WEST STREET, UNIT C
MILBURY, MA 01527

ELECTRICAL ENGINEER:
JOHN J. MURPHY, JR. ELECTRICAL
CONSTRUCTION AND ENGINEERING, INC.
379 LIBERTY STREET
ROCKLAND, MA 02370



	03/06/19	ISSUED FOR PAVED BOARD ENDORSEMENT
	02/13/19	REVISED PER PEER REVIEW
	01/31/19	COMMENTS REISSUED TO C REVISED AND REISSUED FOR AMENDED NOI
	01/31/19	REVISED AND REISSUED FOR SITE PLAN REVIEW
	01/07/19	ISSUED FOR DESIGN REVIEW COMMITTEE REVIEW
	12/27/18	ISSUED FOR NOTICE OF INTENT
	12/20/18	ISSUED FOR SITE PLAN REVIEW
REV	DATE	DESCRIPTION

DATE	
SCALE	NT
DRAWN BY	AC
CHECKED BY	PS
PROJECT NO.	18043.0

BUILDING:
SHEET TITLE:

DETAILS V

DRAWING NO. C-505

APPROVED BY:
TOWN OF MEDWAY PLANNING AND
ECONOMIC DEVELOPMENT BOARD

[Signature]
[Signature]

DATE: 3-26-2019



**TOWN OF
MEDWAY**

NEW DPW FACILITY

OWNER:
TOWN OF MEDWAY
155 VILLAGE STREET
MEDWAY, MA 02053

ARCHITECT:
HELENE • KARL
Architects, Inc.
61 Myfield Drive, Orono, Maine 04468, 01410

CIVIL ENGINEER:
SYMME, MAIN & McKEE ASSOCIATES
1000 MASSACHUSETTS AVENUE
CAMBRIDGE, MA 02138

STRUCTURAL ENGINEER:
SYMME, MAIN & McKEE ASSOCIATES
1000 MASSACHUSETTS AVENUE
CAMBRIDGE, MA 02138

MECHANICAL ENGINEER:
SEAMAN ENGINEERING CORP.
22 WEST STREET, UNIT C
MILLBURY, MA 01527

ELECTRICAL ENGINEER:
JOHN J. MURPHY, JR. ELECTRICAL
CONSTRUCTION AND ENGINEERING, INC.
379 LIBERTY STREET
ROCKLAND, MA 02370

STAMP




03/06/19	ISSUED FOR FILED BOARD
02/13/19	INCOMPLETION
01/31/19	REVISED FOR PERM REVIEW
01/31/19	REVISED AND REISSUED FOR
01/31/19	AMENDED NOT
01/07/19	REVISED AND REISSUED FOR
12/27/18	REVISED FOR DESIGN REVIEW
12/20/18	COMMITTEE REVIEW
	REVISED FOR NOTICE OF
	INTENT
	REVISED FOR SITE PLAN
	REVIEW

REV	DATE	DESCRIPTION

DATE	VARIES
SCALE	VARIES
DRAWN BY	ACO
CHECKED BY	PSG
PROJECT NO.	18043.00

BUILDING:	
SHEET TITLE:	
SEWER PROFILE I	

DRAWING NO.	C-601
-------------	-------

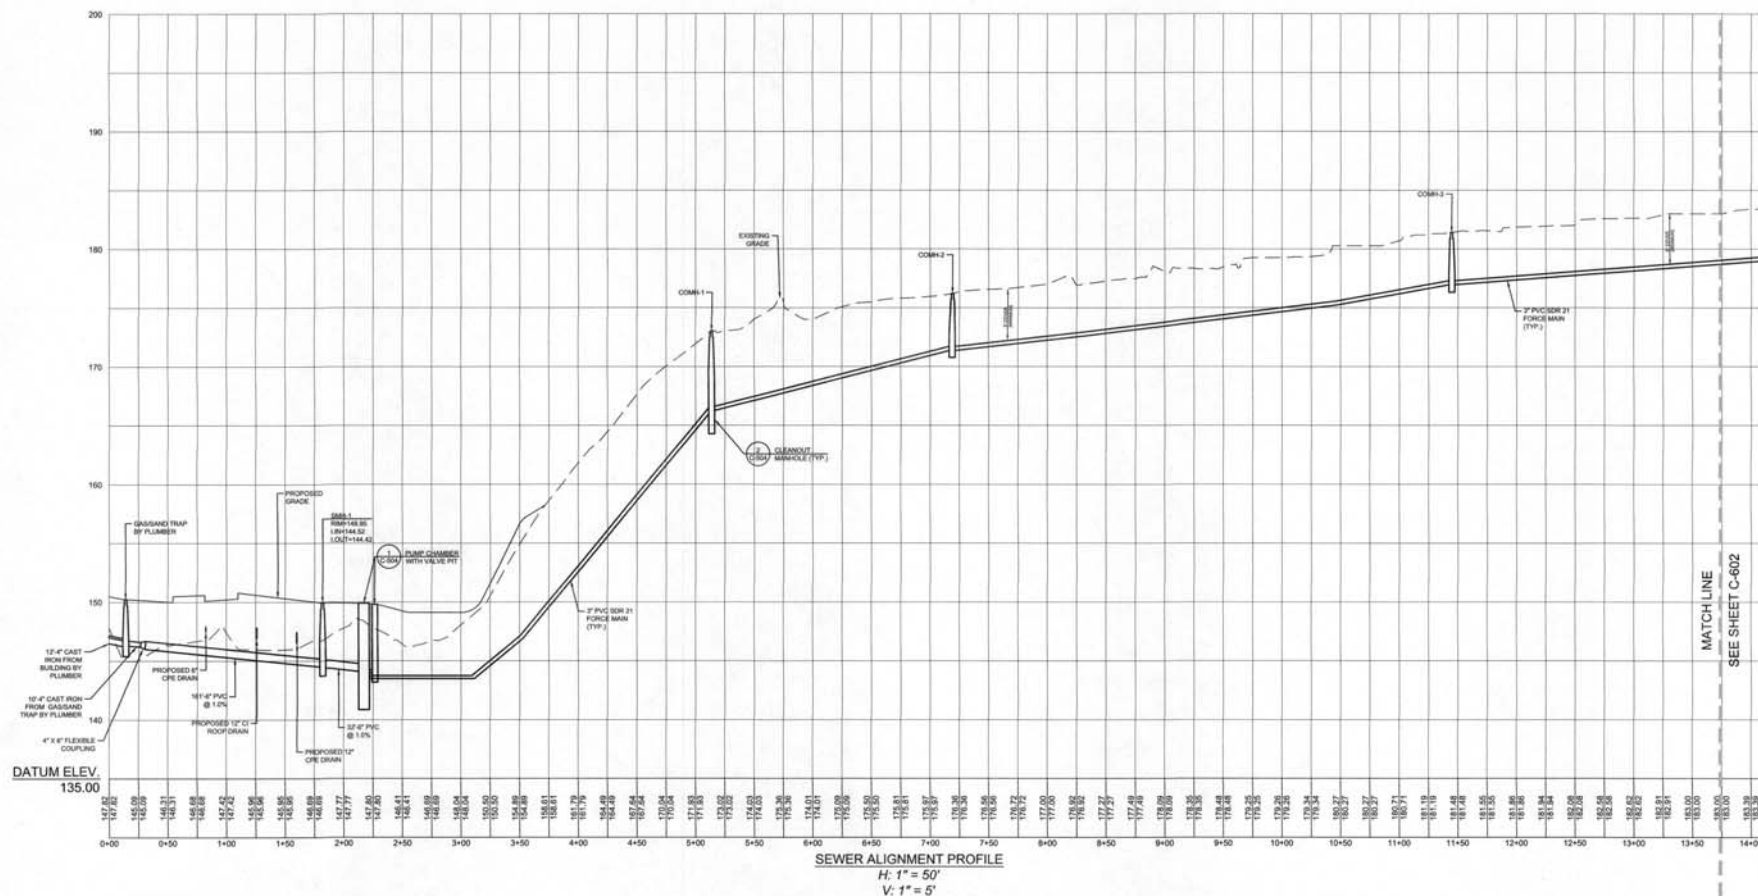

APPROVED BY:
TOWN OF MEDWAY PLANNING AND
ECONOMIC DEVELOPMENT BOARD

[Signature]
[Signature]
[Signature]

DATE: 3-26-2019



TOWN OF MEDWAY

NEW DPW FACILITY

OWNER:
TOWN OF MEDWAY
155 VILLAGE STREET
MEDWAY, MA 02053

ARCHITECT:
HELENE K. KARL
Architects, Inc.
51 State Street, 2nd Floor, Medway, MA 02053

CIVIL ENGINEER:
SYMMES, MAINE & McKEE ASSOCIATES
1000 MASSACHUSETTS AVENUE
CAMBRIDGE, MA 02138

STRUCTURAL ENGINEER:
SYMMES, MAINE & McKEE ASSOCIATES
1000 MASSACHUSETTS AVENUE
CAMBRIDGE, MA 02138

MECHANICAL ENGINEER:
SEAMAN ENGINEERING CORP.
22 WEST STREET, UNIT C
MILLBURY, MA 01527

ELECTRICAL ENGINEER:
JOHN J. MURPHY, JR. ELECTRICAL
CONSTRUCTION AND ENGINEERING, INC.
379 LIBERTY STREET
ROCKLAND, MA 02370





REV	DATE	DESCRIPTION
03/06/19		ISSUED FOR PEERS BOARD
02/13/19		ENDORSEMENT
01/31/19		REVISED FOR PEER REVIEW
01/31/19		COMMENTS REQUESTED TO C.C.
01/31/19		REVISED AND REQUESTED FOR
01/31/19		AMENDED NO.
01/31/19		REVISED AND REQUESTED FOR
01/31/19		REVIEW PLAN REVIEW
01/07/19		REQUESTED FOR DESIGN REVIEW
12/27/18		COMMITTEE REVIEW
12/27/18		REQUESTED FOR NOTICE OF
12/27/18		NOTICE
12/27/18		REQUESTED FOR SITE PLAN
12/27/18		REVIEW

DATE: _____
SCALE: _____ VARIES
DRAWN BY: ACO
CHECKED BY: PSG
PROJECT NO. 18043.00

BUILDING: _____
SHEET TITLE:
**SEWER
PROFILE II**

DRAWING NO.
C-602

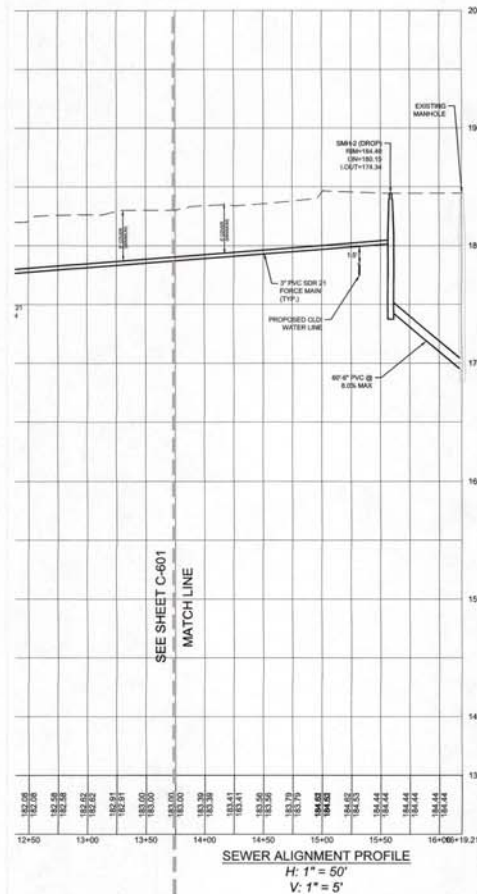

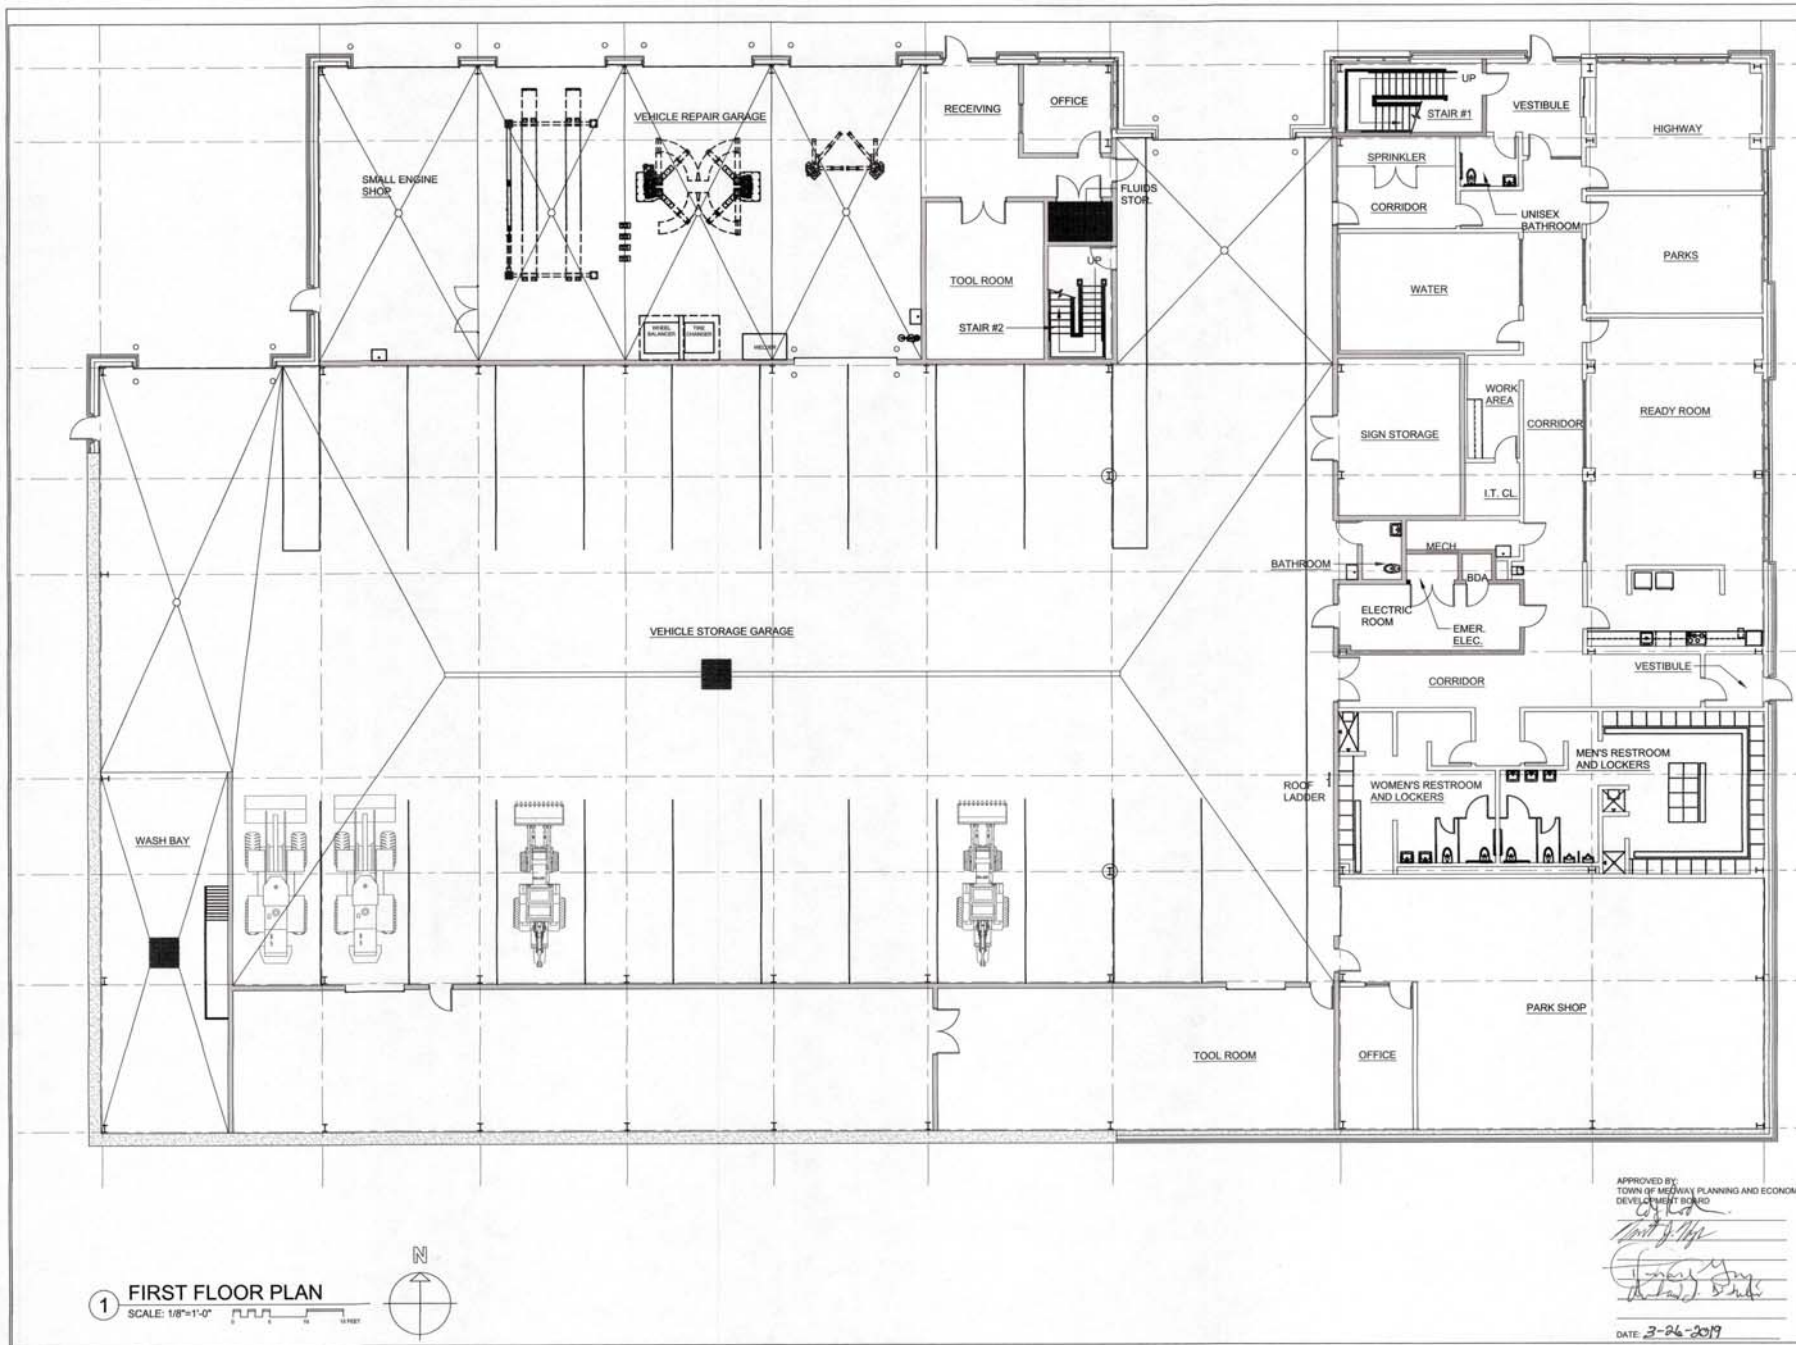

1 FIRST FLOOR PLAN

SCALE: 1/8"=1'-0"

0 5 10 15 FEET



APPROVED BY:
TOWN OF MEDWAY PLANNING AND ECONOMIC
DEVELOPMENT BOARD

[Signature]
[Signature]
[Signature]

DATE: 3-26-2019



TOWN OF MEDWAY NEW DPW FACILITY

OWNER:
TOWN OF MEDWAY
155 VILLAGE STREET
MEDWAY, MA 02053

ARCHITECT:
HELENE • KARL
Architects, Inc.
61 Skyline Drive, Canton, Massachusetts 01920

CIVIL ENGINEER:
SYMES, MAIR & MAIR ASSOCIATES
1000 MASSACHUSETTS AVENUE
CAMBRIDGE, MA 02138

STRUCTURAL ENGINEER:
SYMES, MAIR & MAIR ASSOCIATES
1000 MASSACHUSETTS AVENUE
CAMBRIDGE, MA 02138

MECHANICAL ENGINEER:
SEAMAN ENGINEERING CORP.
22 WEST STREET, UNIT C
MILLBURY, MA 01527

ELECTRICAL ENGINEER:
JOHN J. MURPHY, JR. ELECTRICAL
CONSTRUCTION AND ENGINEERING, INC.
379 LIBERTY STREET
ROCKLAND, MA 02370



REV	DATE	DESCRIPTION
03/06/19		ISSUED FOR PERMITS BOARD
01/31/19		FOR SITE PLAN REVIEW
12/20/18		FOR SITE PLAN REVIEW
11/28/18		FOR DESIGN REVIEW
11/08/18		FOR PRE-APPLICATION


DATE: 3-26-2019
SCALE: 1/8" = 1'-0"
DRAWN BY: MTV
CHECKED BY: GKY
PROJECT NO.: 18043.00

BUILDING:

SHEET TITLE:

FIRST FLOOR PLAN

DRAWING NO.: A-101

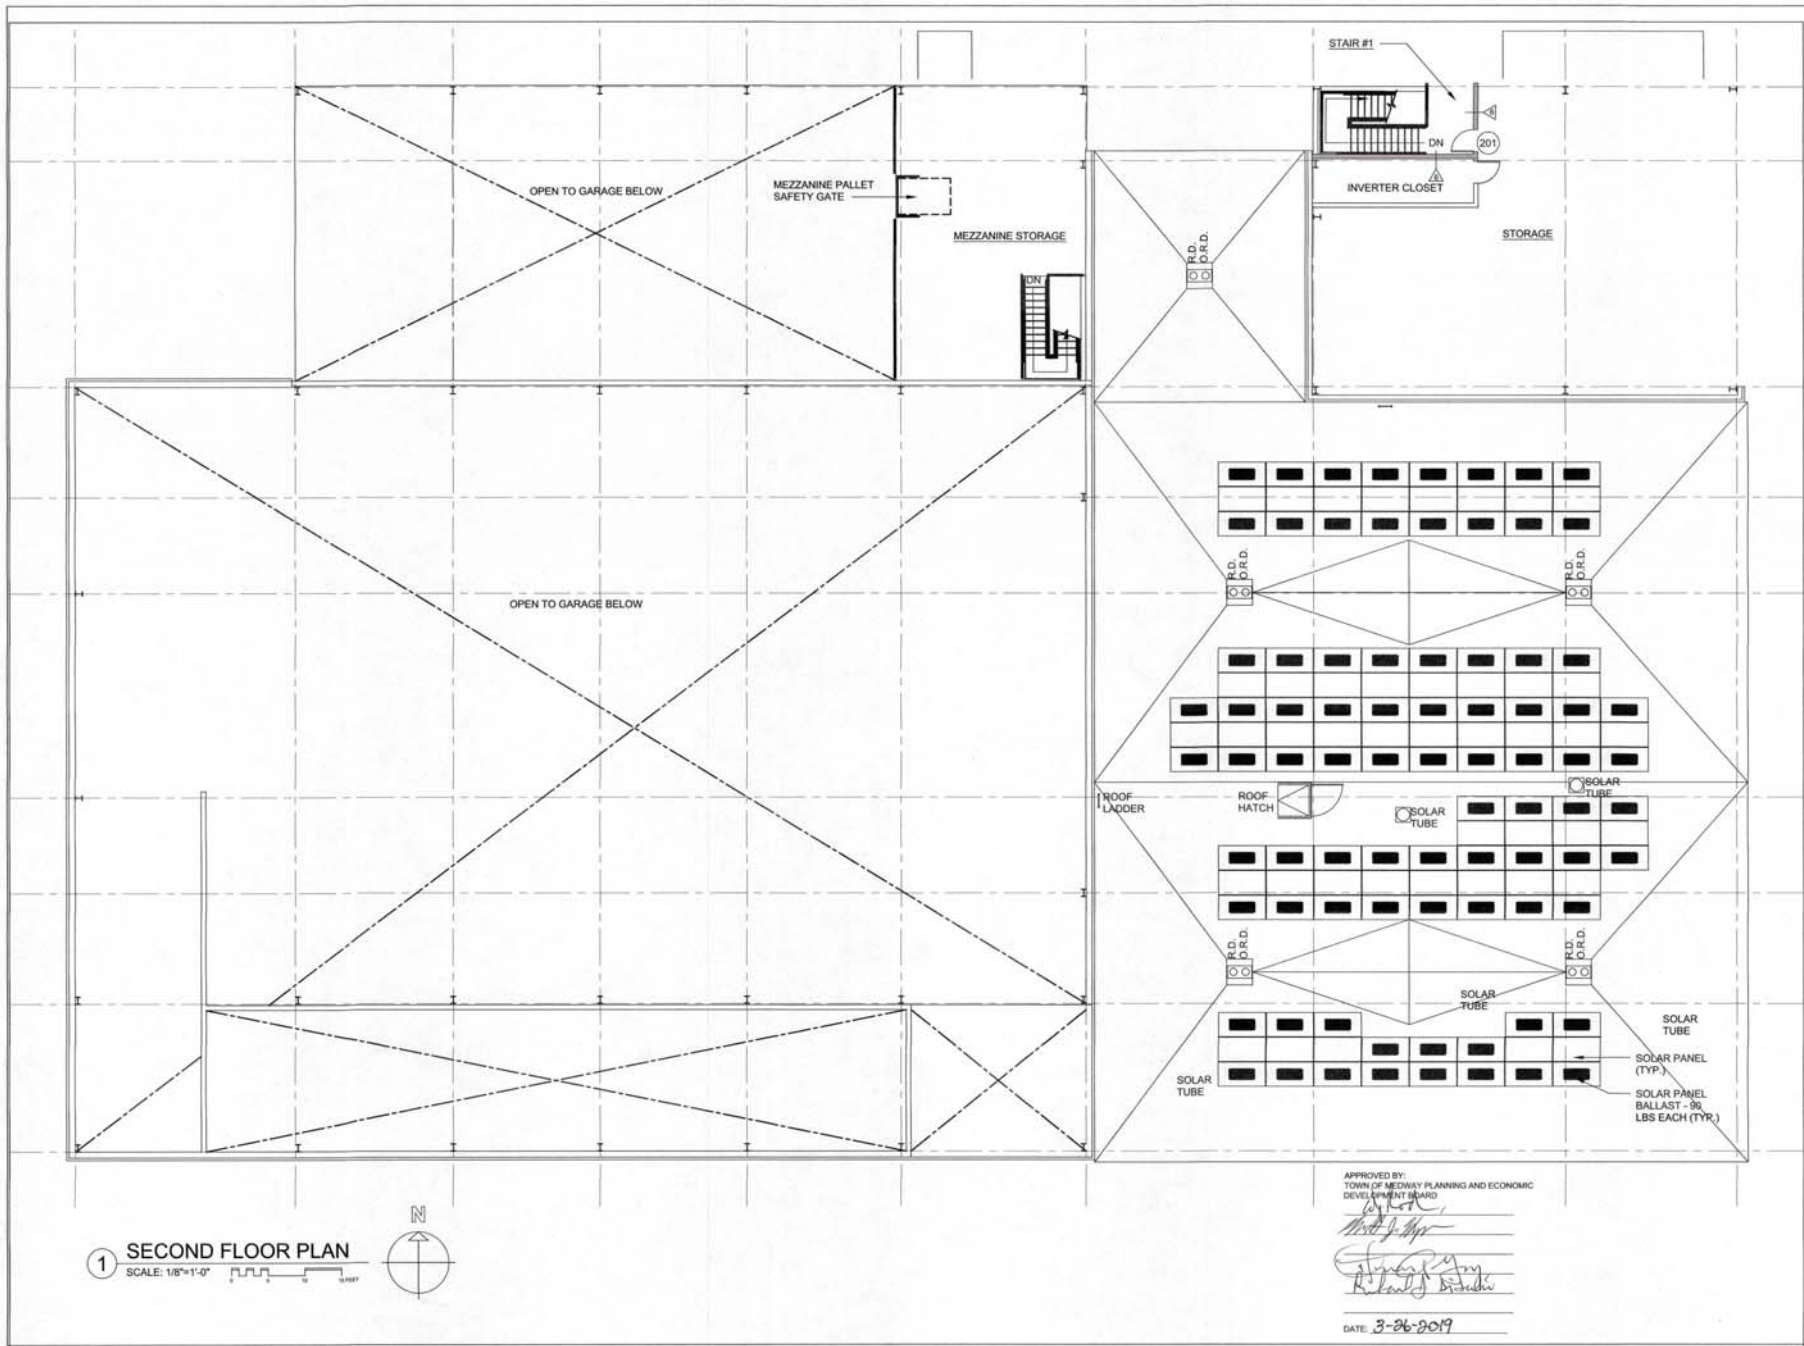

1 SECOND FLOOR PLAN
SCALE: 1/8"=1'-0"



APPROVED BY:
TOWN OF MEDWAY PLANNING AND ECONOMIC
DEVELOPMENT BOARD

[Signature]
[Signature]
[Signature]

DATE: 3-26-2019



TOWN OF MEDWAY NEW DPW FACILITY

OWNER:
TOWN OF MEDWAY
155 VILLAGE STREET
MEDWAY, MA 02053

ARCHITECT:
HELENE • KARL
Architects, Inc.
61 Wytheville Drive, Glaston, Massachusetts 01930

CIVIL ENGINEER:
SYMMES, MANN & MCKEE ASSOCIATES
1000 MASSACHUSETTS AVENUE
CAMBRIDGE, MA 02138

STRUCTURAL ENGINEER:
SYMMES, MANN & MCKEE ASSOCIATES
1000 MASSACHUSETTS AVENUE
CAMBRIDGE, MA 02138

MECHANICAL ENGINEER:
SEAMAN ENGINEERING CORP.
22 WEST STREET, UNIT C
MILLBURY, MA 01527

ELECTRICAL ENGINEER:
JOHN J. MURPHY, JR. ELECTRICAL
CONSTRUCTION AND ENGINEERING, INC.
379 LIBERTY STREET
ROCKLAND, MA 02370



REV	DATE	DESCRIPTION
03/06/19		ISSUED FOR PRELIMINARY BOARD REVIEW
01/31/19		REVISED AND RESUBMITTED FOR PRELIMINARY BOARD REVIEW
12/20/18		ISSUED FOR PRELIMINARY BOARD REVIEW
11/28/18		ISSUED FOR PRELIMINARY BOARD REVIEW
11/08/18		ISSUED FOR PRELIMINARY BOARD REVIEW

DATE	1/8" = 1'-0"
SCALE	MTV
DRAWN BY	GKY
CHECKED BY	18043.00
PROJECT NO.	

BUILDING:

SHEET TITLE:

A-102

DRAWING NO.
SECOND FLOOR AND
LOWER ROOF PLAN



**TOWN OF
MEDWAY**
NEW DPW FACILITY

OWNER:
TOWN OF MEDWAY
155 VILLAGE STREET
MEDWAY, MA 02053

ARCHITECT:
HELENE + KARL
Architects, Inc.
A/I: 344 Fields Drive, Groton, Massachusetts 01433

CIVIL ENGINEER:
SYMMES, MAINE & MCKEE ASSOCIATES
1000 MASSACHUSETTS AVENUE
CAMBRIDGE, MA 02138

STRUCTURAL ENGINEER:
SYMMES, MAINE & MCKEE ASSOCIATES
1000 MASSACHUSETTS AVENUE
CAMBRIDGE, MA 02138

MECHANICAL ENGINEER:
SEAMAN ENGINEERING CORP.
22 WEST STREET, UNIT C
MILLBURY, MA 01527

ELECTRICAL ENGINEER:
JOHN J. MURPHY, JR., ELECTRICAL
CONSTRUCTION AND ENGINEERING, INC.
379 LIBERTY STREET
ROCKLAND, MA 02370

STAMP



REV	DATE	DESCRIPTION
	03/06/19	ISSUED FOR PRE-BOARD ENGAGEMENT
	01/31/19	REVISED AND ISSUED FOR SITE PLAN REVIEW
	12/20/18	ISSUED FOR SITE PLAN REVIEW
	11/28/18	ISSUED FOR DESIGN REVIEW COMMITTEE REVIEW
	11/08/18	ISSUED FOR PRE-APPLICATION MEETING WITH PLANNING BOARD

DATE	
SCALE	1/8" = 1'-0"
DRAWN BY	MTV
CHECKED BY	GKV
PROJECT NO.	18043.00


BUILDING:

SHEET TITLE:


**EXTERIOR
ELEVATIONS
SHEET 1**

DRAWING NO.

A-301

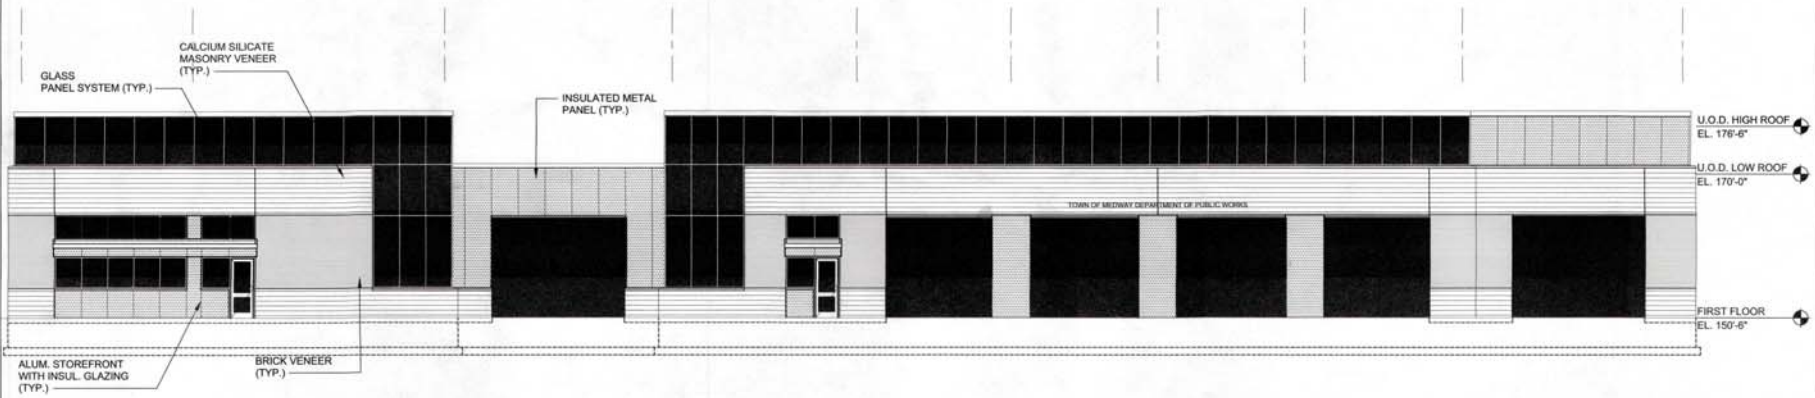

1 NORTH ELEVATION
SCALE: 1/8"=1'-0"

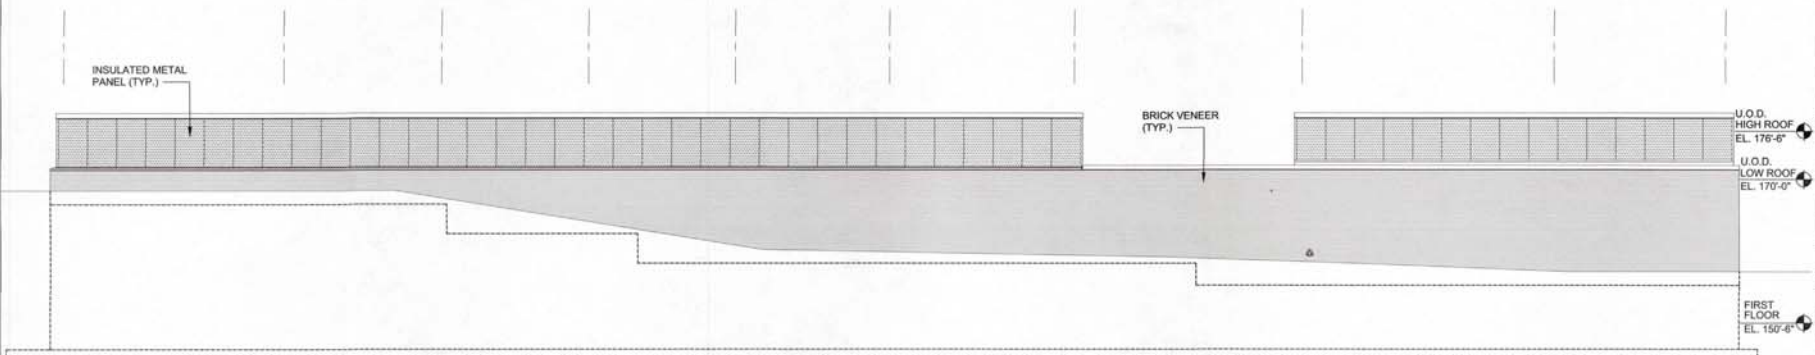

2 SOUTH ELEVATION
SCALE: 1/8"=1'-0"

APPROVED BY:
TOWN OF MEDWAY PLANNING AND ECONOMIC
DEVELOPMENT BOARD

[Signature]
[Signature]
[Signature]

DATE: 3-26-2019



**TOWN OF
MEDWAY**
NEW DPW FACILITY

OWNER:
TOWN OF MEDWAY
155 VILLAGE STREET
MEDWAY, MA 02053

ARCHITECT:
HELENE • KARL
Architects, Inc.
61 Baylands Drive, Grafton, Massachusetts 01930

CIVIL ENGINEER:
SYMMES, MANN & MCKEE ASSOCIATES
1000 MASSACHUSETTS AVENUE
CAMBRIDGE, MA 02138

STRUCTURAL ENGINEER:
SYMMES, MANN & MCKEE ASSOCIATES
1000 MASSACHUSETTS AVENUE
CAMBRIDGE, MA 02138

MECHANICAL ENGINEER:
SEAMAN ENGINEERING CORP.
22 WEST STREET, UNIT C
MILLBURY, MA 01527

ELECTRICAL ENGINEER:
JOHN J. MURPHY, JR. ELECTRICAL
CONSTRUCTION AND ENGINEERING, INC.
379 LIBERTY STREET
ROCKLAND, MA 02370




REV	DATE	DESCRIPTION
	03/06/19	ISSUED FOR PERMITS BOARD
	01/31/19	REVISION
	12/20/18	FOR SITE PLAN REVIEW
	11/28/18	ISSUED FOR DESIGN REVIEW
	11/08/18	COMMITTEE REVIEW
		ISSUED FOR PRE-APPLICATION
		MEETING PLANNING BOARD

DATE	1/8" = 1'-0"
DRAWN BY	MTV
CHECKED BY	GKY
PROJECT NO.	18043.00


BUILDING:
SHEET TITLE:

**EXTERIOR
ELEVATIONS
SHEET 2**

DRAWING NO.
A-302

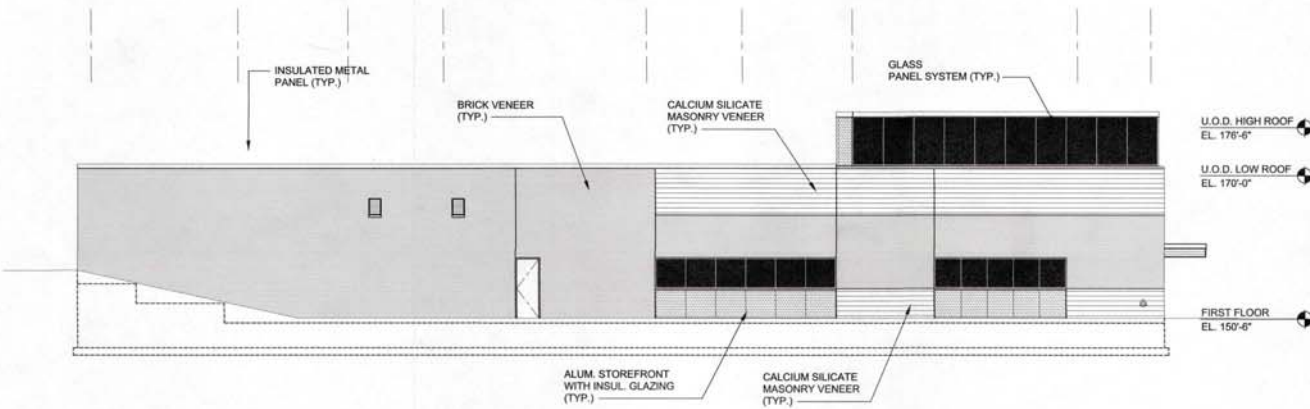

3 EAST ELEVATION
SCALE: 1/8"=1'-0"

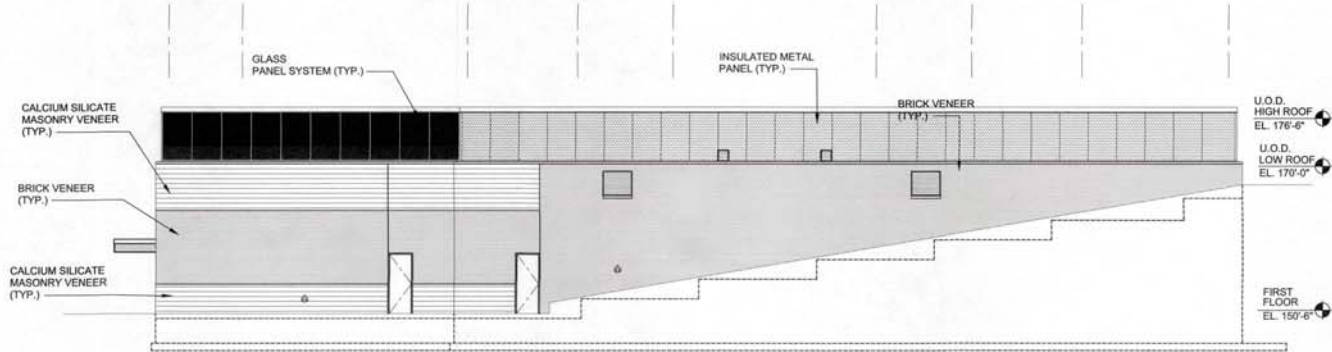

4 WEST ELEVATION
SCALE: 1/8"=1'-0"

APPROVED BY:
TOWN OF MEDWAY PLANNING AND ECONOMIC
DEVELOPMENT BOARD
[Signature]
[Signature]
DATE: 3-26-2019



APPROVED BY:
TOWN OF MEDWAY PLANNING AND ECONOMIC
DEVELOPMENT BOARD

10/1/20
 10/1/20
 10/1/20

DATE: 3-26-2019

TOWN OF
MEDWAY

NEW DPW FACILITY

OWNER:

TOWN OF MEDWAY
155 VILLAGE STREET
MEDWAY, MA 02053

ARCHITECT:



6.1 Syntactic Theory, Chapter, Massachusetts 01462

CIVIL ENGINEER:

SYMMES, MAINI & McKEE ASSOCIATES
1000 MASSACHUSETTS AVENUE
CAMBRIDGE, MA 02138

STRUCTURAL ENGINEER:

SYMMES, MAINI & MCKEE ASSOCIATES
1000 MASSACHUSETTS AVENUE
CAMBRIDGE, MA 02138

MECHANICAL ENGINEER:

SEAMAN ENGINEERING CORP.
22 WEST STREET, UNIT C
MILLBURY, MA 01527

ELECTRICAL ENGINEER:

JOHN J. MURPHY, JR. ELECTRICAL
CONSTRUCTION AND ENGINEERING, INC.
379 LIBERTY STREET
ROCKLAND, MA 02370

STAMP



	01/31/19	ISSUED FOR SITE PLAN REVIEW
	12/20/18	ISSUED FOR SITE PLAN REVIEW
	11/28/18	ISSUED FOR DESIGN REVIEW COMMITTEE REVIEW
	11/08/18	ISSUED FOR PRE-APPLICATION MEETING WITH PLANNING BOARD
REV	DATE	DESCRIPTION

DATE	
SCALE	NT
DRAWN BY	M7
CHECKED BY	GK
PROJECT NO.	18043.0


BUILDING:

SHEET TITLE:

RENDERINGS

DRAFTING NO.

A-303

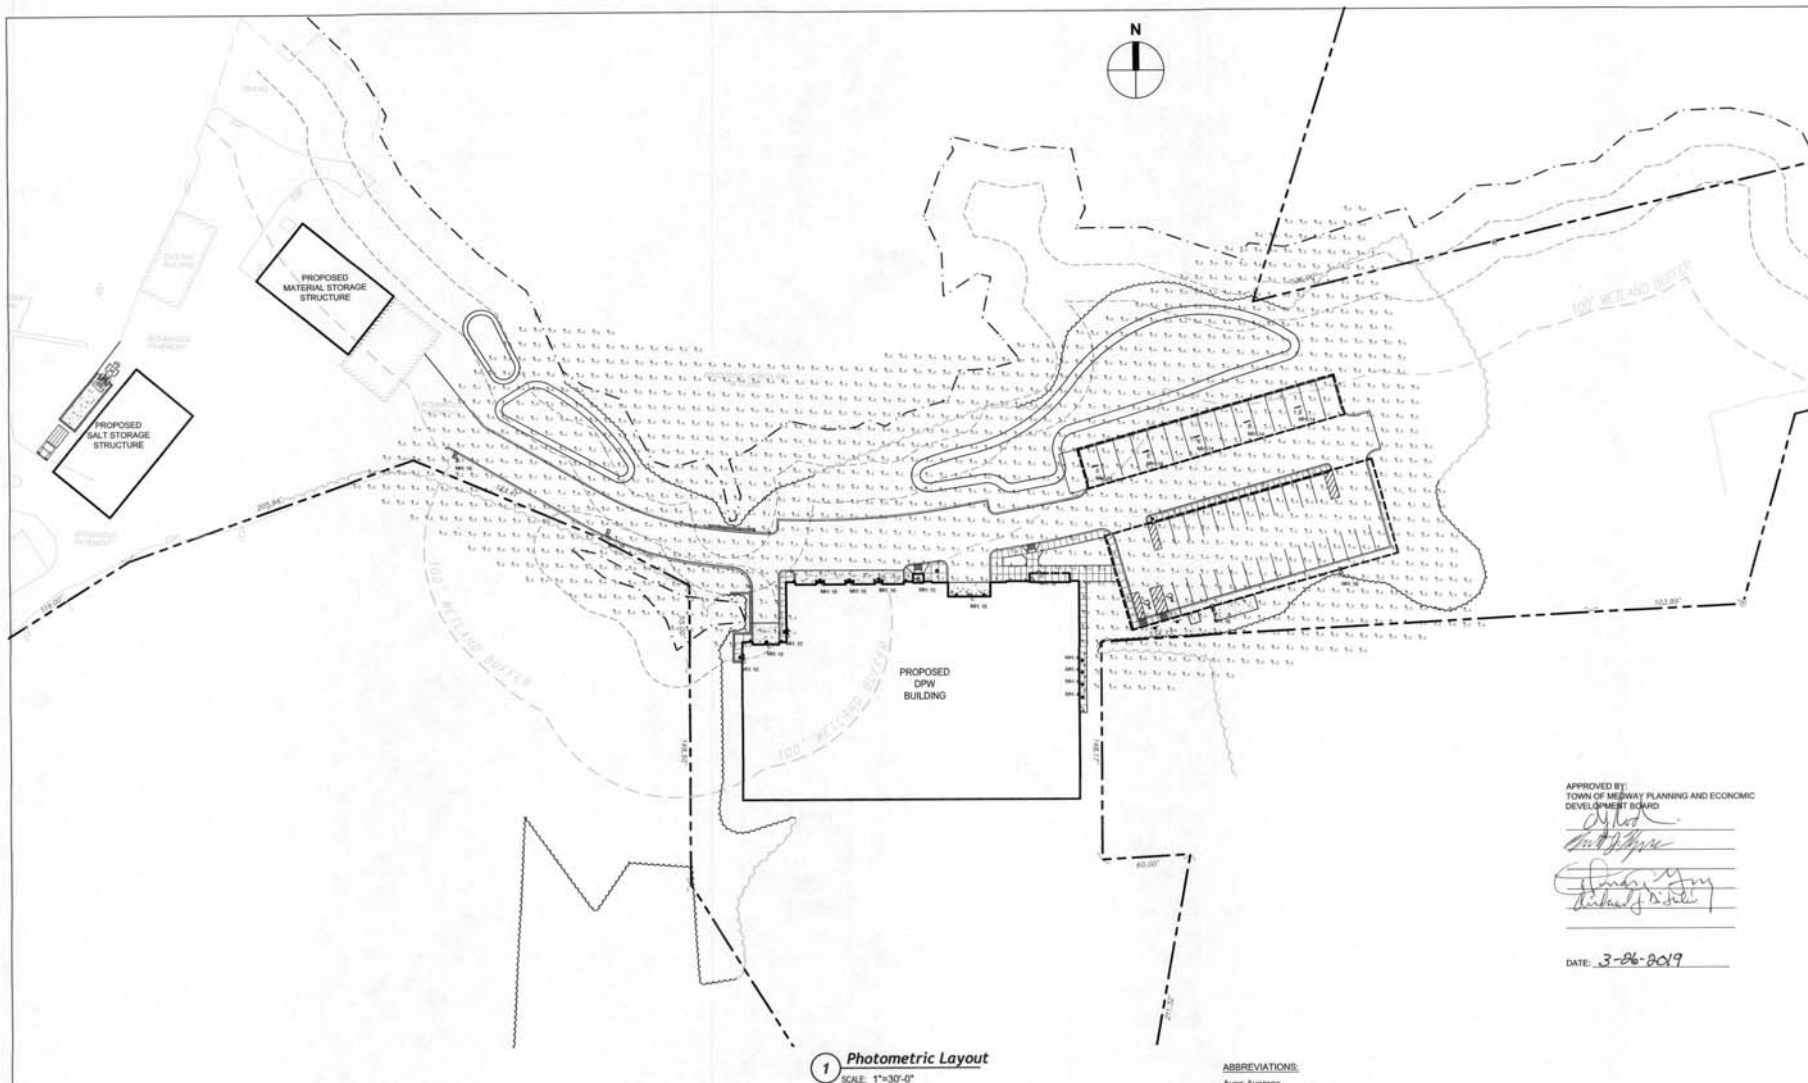

Symbol	Qty	Label	Description	LLF	Lum. Lumens	Lum. Watts
→	2	A	XTRALIGHT VNTLEDM022004SHDM510X0BZHDHS	0.850	15013	218.3
→	2	B	XTRALIGHT VNTLEDM021003MNDMS10X0BZHDHS	0.850	9174	104.6
→	5	C	XTRALIGHT VNTW-8000L-40K-DIM-45-BZ	0.850	8496	79.6
→	5	D	XTRALIGHT VNTW-3500L-50K-DIM-3M-BZ	0.850	3452	27.9
→	5	E	XTRALIGHT VTE4-5000L-40K-DIM-SFA	0.850	5268	44.4
●	4	F	LUMASCAPE LS201LED-6H6-NARROW BEAM-23-CB-DIM TO 10%	0.850	403	6.0

Label	CalcType	Units	Avg	Max	Min	Avg/Min	Max/Min
Site Points	Illuminance	Fc	0.67	8.8	0.0	N.A.	N.A.

ABBREVIATIONS:

Avg= Average
 AFON= Above Finished Grade
 CF= Compact Fluorescent
 CV= Coefficient of variation
 fc= Footcandles
 HPS= High Pressure Sodium
 LLF= Light Loss Factor
 MH= Mounting Height
 NTS= Not to Scale
 PSBH= Pulse Start Metal Halide
 SF= Square Foot
 W= Watts

NOTES:

- CALCULATION POINTS INDICATED ARE BASED ON MAINTAINED FOOTCANDLE (FC) LEVELS AFTER A LIGHT LOSS FACTOR (LLF) IS APPLIED TO FIXTURE. REFER TO SCHEDULES FOR LLF AND LUMEN INFORMATION.
- REFER TO PLAN FOR FIXTURE MOUNTING HEIGHTS.
- CALCULATION POINTS TAKEN AT GRADE.

GRAPHIC SCALE



TOWN OF MEDWAY

NEW DPW FACILITY

OWNER:

TOWN OF MEDWAY
155 VILLAGE STREET
MEDWAY, MA 02053

ARCHITECT:

HELENE KARL
Architects, Inc.
41 Wytheville Drive, Groton, Massachusetts 01460

CIVIL ENGINEER:

STANES, MANN & MCKEE ASSOCIATES
1000 MASSACHUSETTS AVENUE
CAMBRIDGE, MA 02138

STRUCTURAL ENGINEER:

STANES, MANN & MCKEE ASSOCIATES
1000 MASSACHUSETTS AVENUE
CAMBRIDGE, MA 02138

MECHANICAL ENGINEER:

SEAMAN ENGINEERING CORP.
22 WEST STREET, UNIT C
MILLBURY, MA 01527

ELECTRICAL ENGINEER:

JOHN J. MURPHY, JR. ELECTRICAL
CONSTRUCTION AND ENGINEERING, INC.
379 LIBERTY STREET
ROCKLAND, MA 02370

STAMP



APPROVED BY:
TOWN OF MEDWAY PLANNING AND ECONOMIC
DEVELOPMENT BOARD

[Signature]
[Signature]
[Signature]

DATE: 3-26-2019

03/06/19	ISSUED FOR PERIOD BOARD
02/13/19	RECEIVED FOR PERIOD REVIEW
01/31/19	COMMENTS REQUIRED TO D.C.
01/31/19	REVISED AND RESUBMITTED FOR
01/31/19	AMENDED NO.
01/31/19	REVISED AND RESUBMITTED FOR
01/07/19	SITE PLAN REVIEW
12/27/18	COMMITTEE REVIEW
12/20/18	COMMITTEE REVIEW
12/20/18	COMMITTEE REVIEW

REV	DATE	DESCRIPTION

DATE	1"=40'
SCALE	ACO
DRAWN BY	PSG
CHECKED BY	PSG
PROJECT NO.	18043.00

BUILDING	
SHEET TITLE	

LIGHTING, LAYOUT & SCHEDULES

DRAWING NO.

SL-1