





F. R. Meisch papers

## **Copyright Notice:**


This material may be protected by copyright law (U.S. Code, Title 17). Researchers are liable for any infringement. For more information, visit

[www.mnhs.org/copyright](http://www.mnhs.org/copyright).

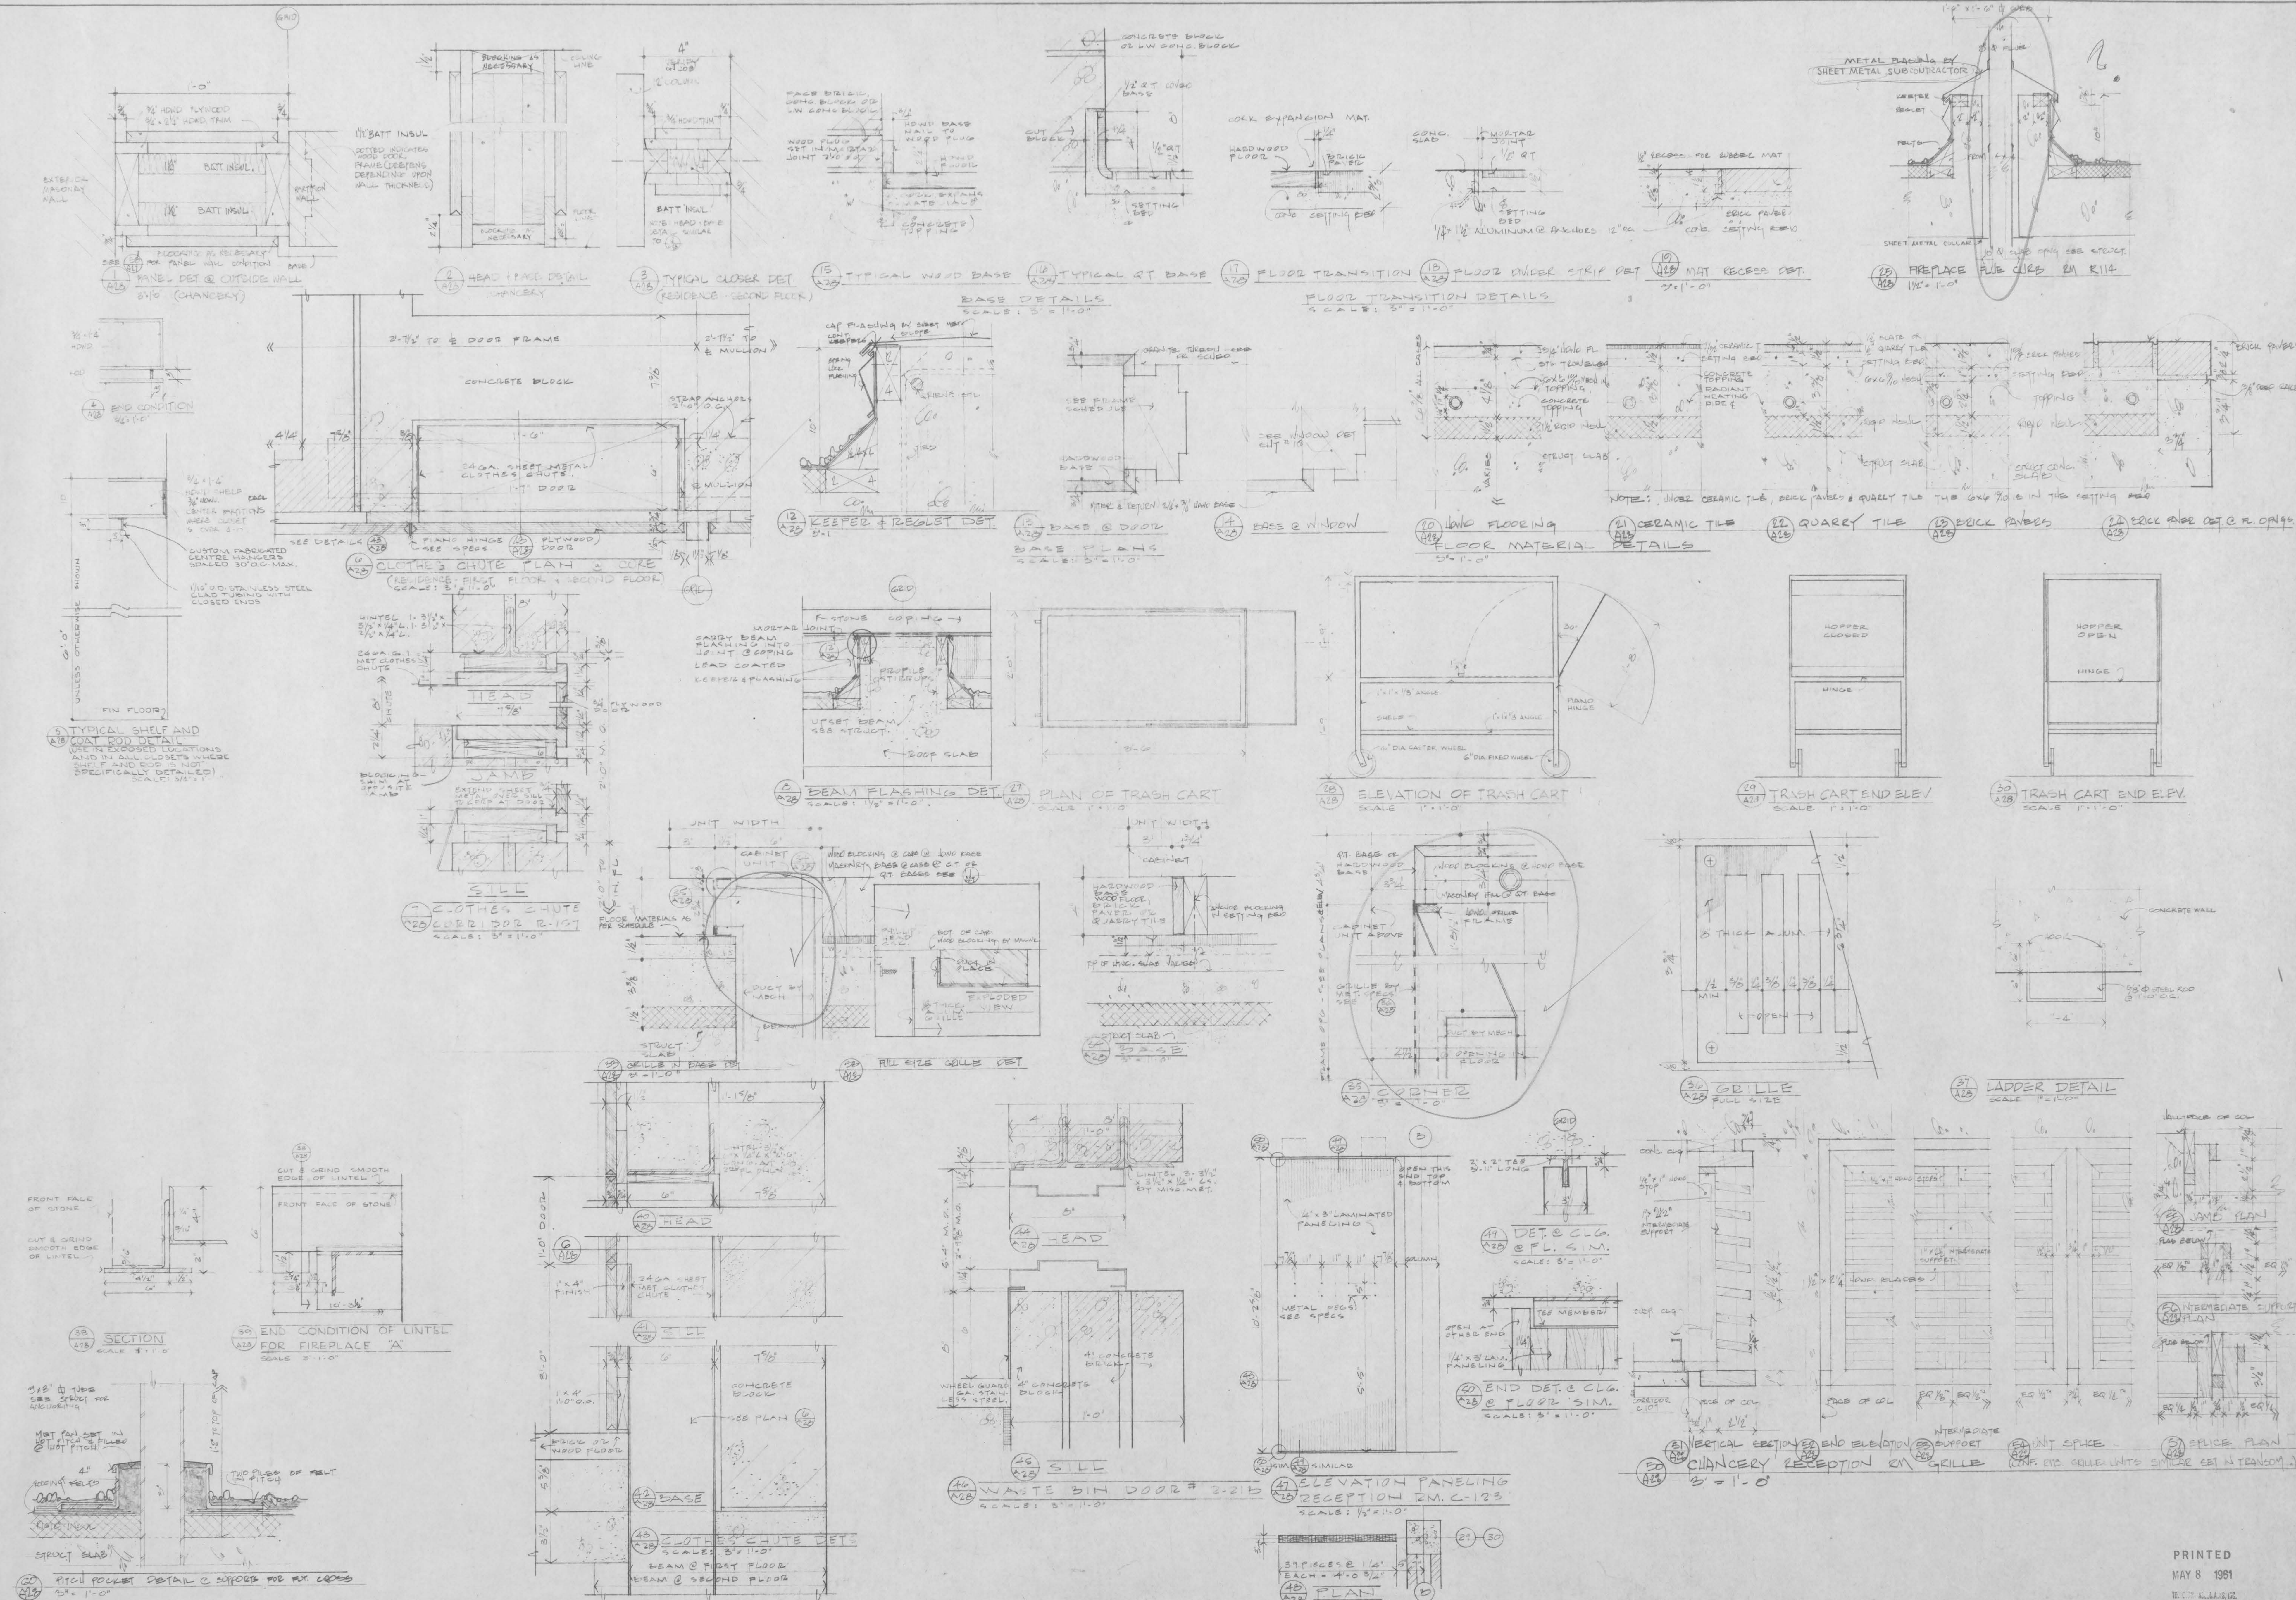


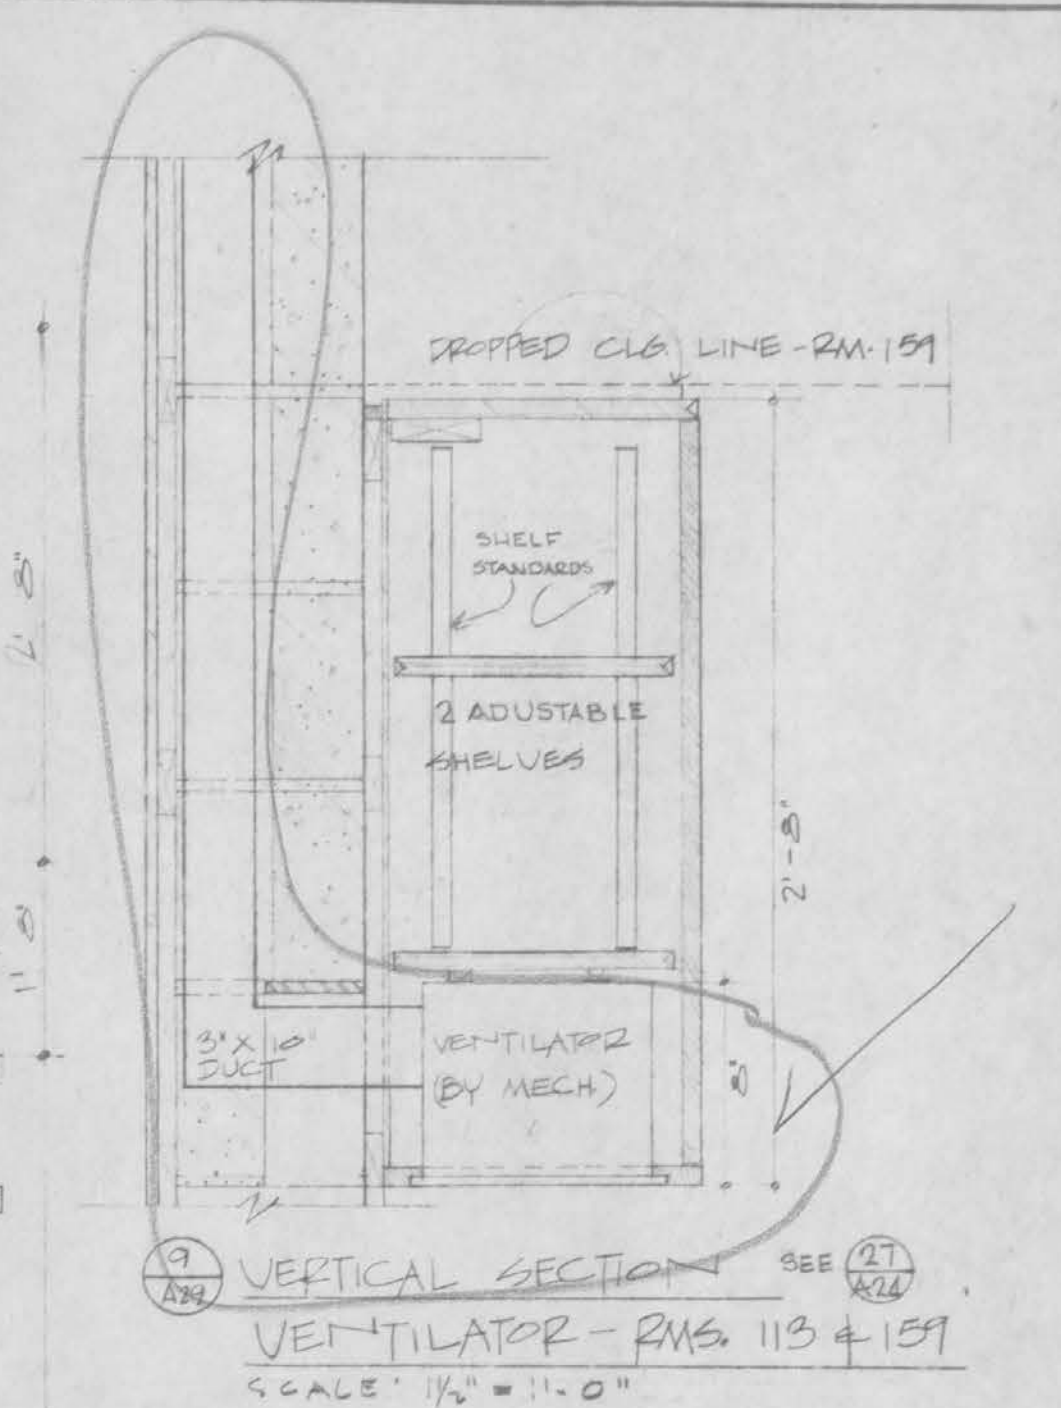


VERTICAL SECTION SEE 21/25  
CABINETS - ROOMS R-113, R-59, C-125

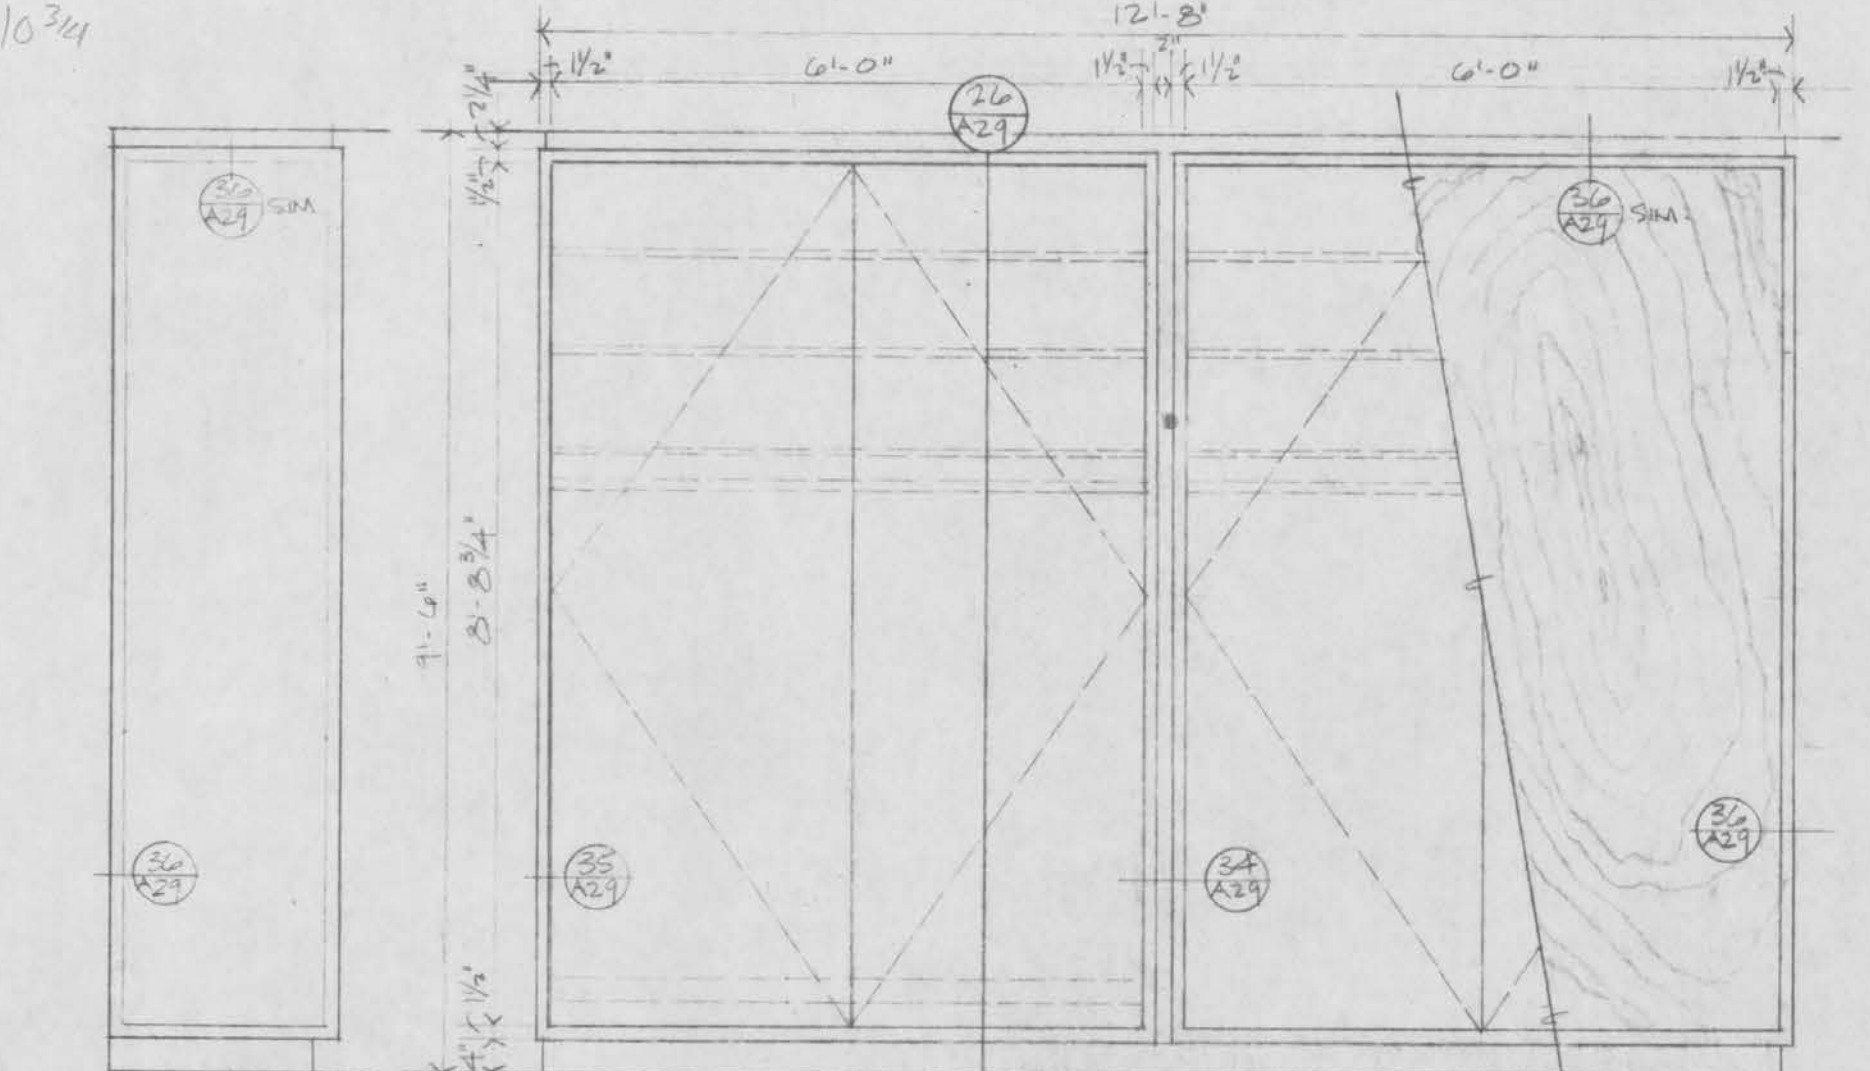



25  
A29 PARTIAL FRONT ELEV. & BACK ELEV.

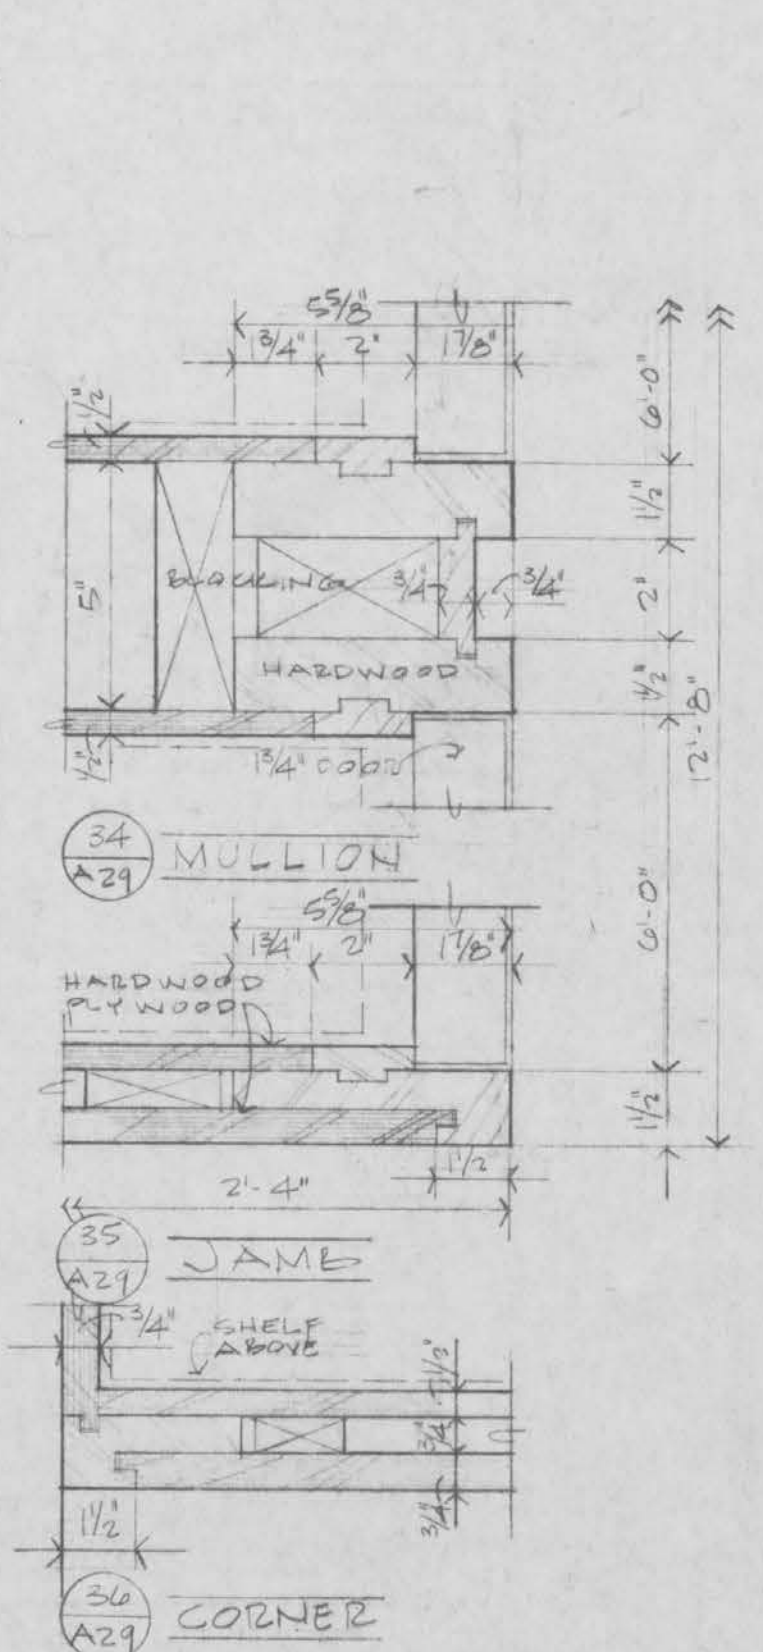

CAB. DETS. RM. 12-210  
SCALE: 3" = 1'-0"

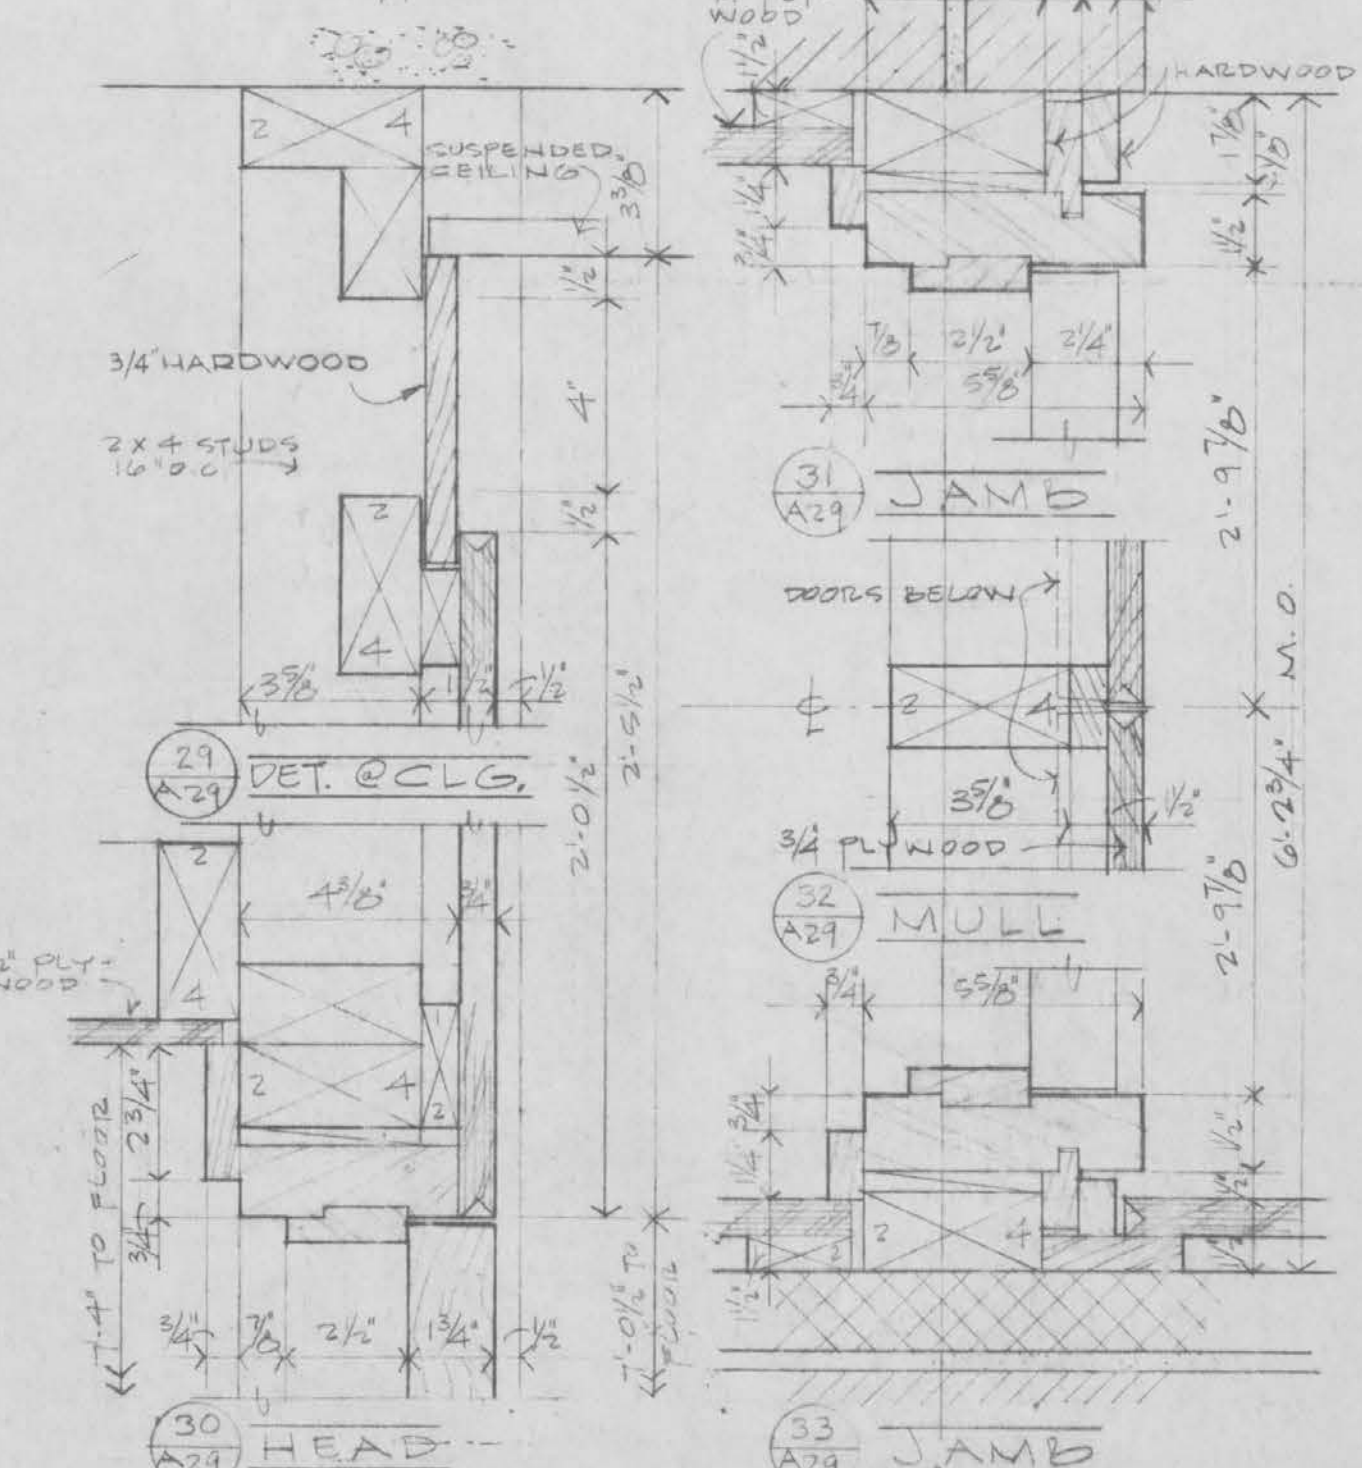

16  
(29) MILLWORK DETAILS @ CLOSET R-212  
SCALE: 3" = 1'-0"

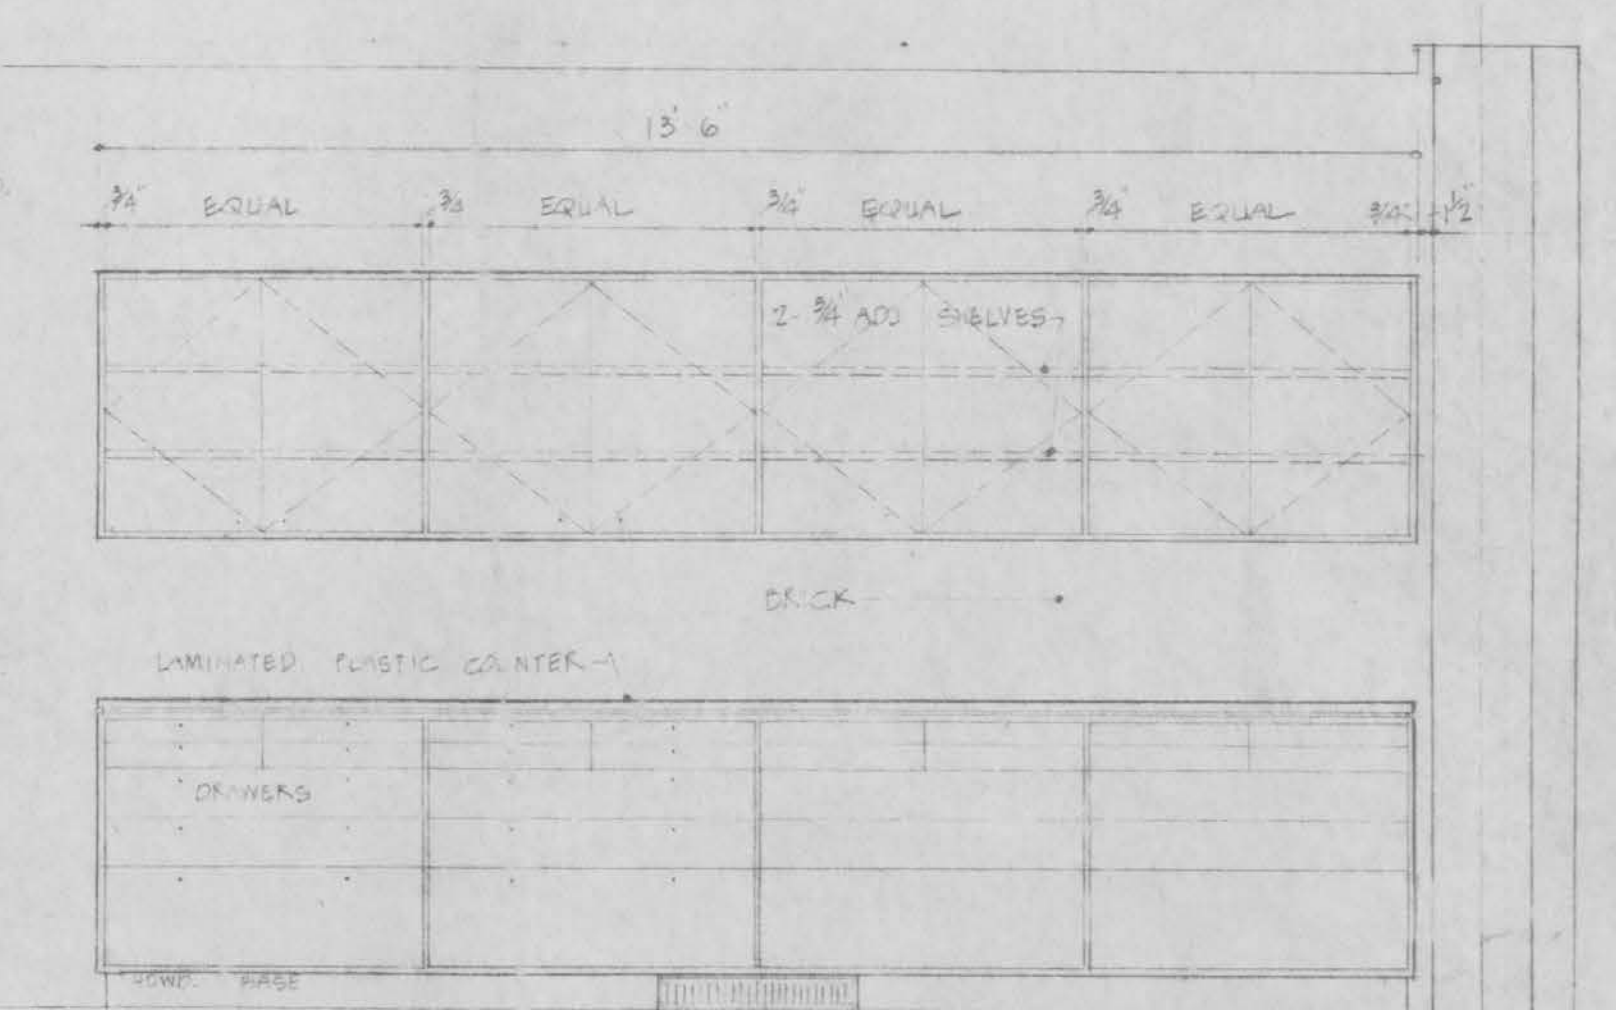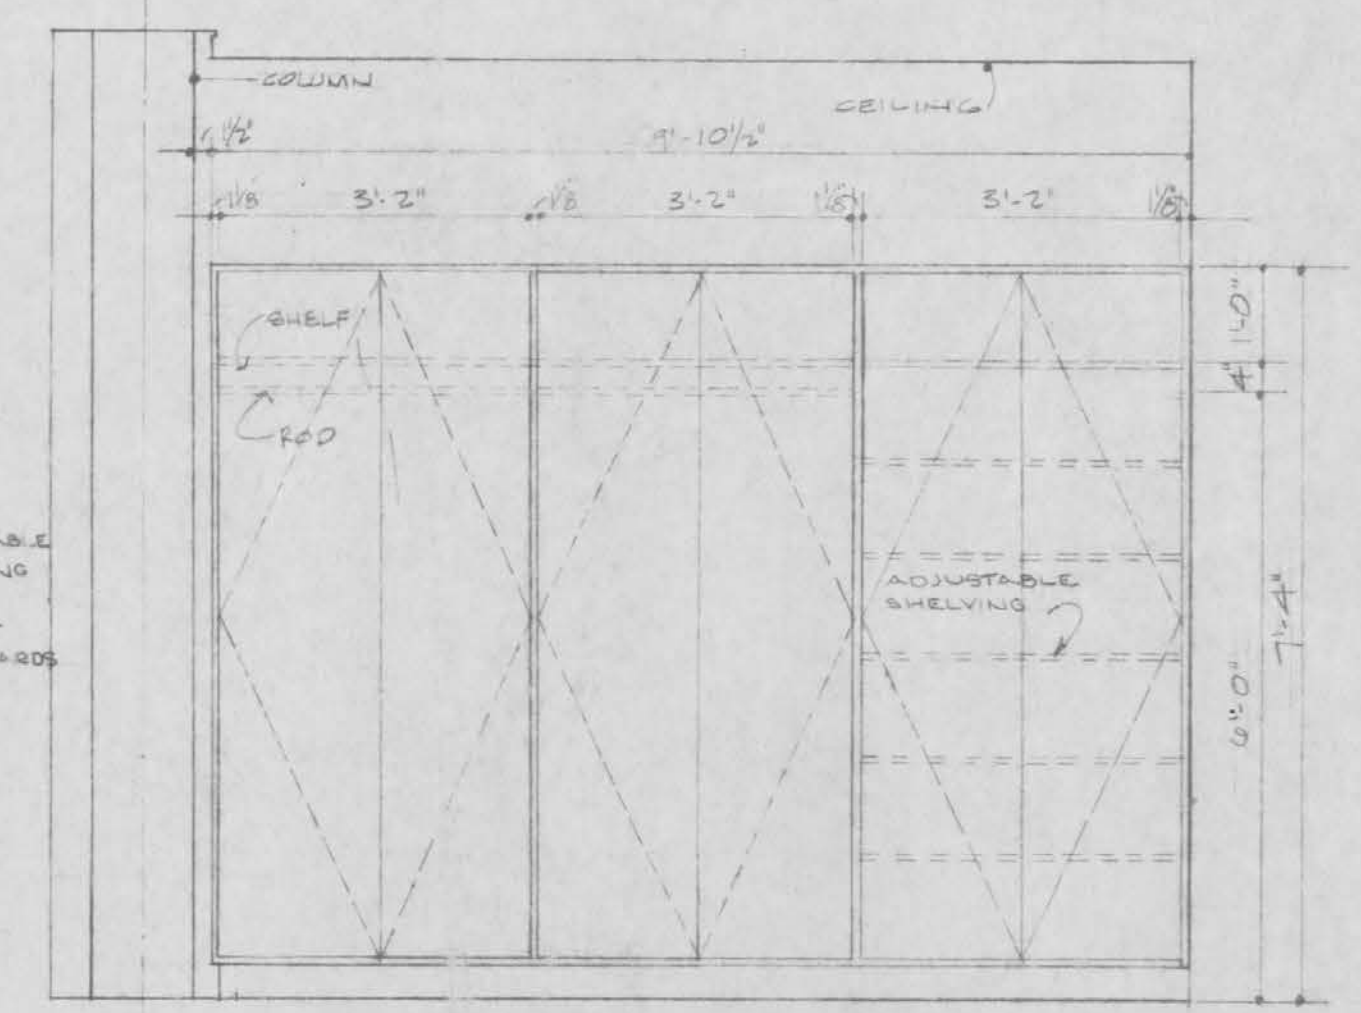





24' x 4' R.A. G.E. L.L.E.  
 BASE BY GEN. CONTR.  
 ELEVATION OF WORK COUNTER R-244



[illegible]

| RESIDENCE |                               |                      | BASEMENT |    |     |-----------|-------------------------------|----------------------|----------|----|-----|-----|------|----------|------------------------|-------------------------------|--------------------------------|-----------------------------------|-------|-----|-----------|----------|----------|----------|-----------------------------|-----------------------------------|-----------------------------------|--------|-------|-------|-----|----------|----------|---------------------------|-------------------|--|--|--|--|--|--|
| R-1       | 3'-0"                         | x 7'-6"              | x 13'-6" | 14 | M1  | MA  | (1)  | 1        | NONE                   | "A" LABEL                     | R-195B                         | PR 3'-2 1/2" x 8'-4 1/2" x 2 1/2" | 10    | W8  | WD        | —        | 57       | 1/2" ASL | SEE (1)                     | R-212                             | PR 2'-7 1/2" x 7'-0 1/2" x 1 3/4" | 9      | W6 WM | WH SM | (4) | 46       | 1/2" ASL | SEE (1)                   | UNDER CUT DOOR 2" |  |  |  |  |  |  |
| R-2       | 3'-0"                         | x 7'-6"              | x 13'-6" | 14 | M2  | MA  | (1)  | 58       | NONE                   |                               | R-136                          | PR 2'-8 1/2" x 8'-4 1/2" x 1 3/4" | 1     | W21 | WD        | —        | 23       | NONE     |                             | R-213A                            | 2'-5 3/8" x 7'-0 1/2" x 1 3/8"    | 8      | W1    | WJ    | —   | 47       | NONE     | SEE (1)                   |                   |  |  |  |  |  |  |
| R-3       | 3'-0"                         | x 7'-6"              | x 13'-6" | 14 | M2  | MA  | (1)  | 6        | NONE                   |                               | R-137                          | PR 2'-8 1/2" x 8'-4 1/2" x 1 3/4" | 1     | W22 | WG        | —        | 35       | 1/2" ASL | ONE DOOR FIXED AS PANEL (1) | R-214A                            | 2'-6" x 7'-0 1/2" x 1 3/8"        | 9      | W10   | WH    | (1) | 25       | 1/2" ASL | SEE (1)                   |                   |  |  |  |  |  |  |
| R-4A      | 3'-4"                         | x 7'-2 1/2" x 13'-6" | 14       | M5 | MA  | (1) | 1    | NONE     | "A" LABEL              | R-138A                        | PR 2'-0" x 8'-4 1/2" x 2 1/2"  | 5                                 | W7    | WD  | —         | 40       | 1/2" ASL | SEE (1)  | R-214B                      | 2'-6" x 7'-0 1/2" x 1 3/8"        | 9                                 | W10    | WH    | (1)   | 27  | 1/2" ASL | SEE (1)  |                           |                   |  |  |  |  |  |  |
| R-4B      | 2'-8"                         | x 7'-2 1/2" x 13'-6" | 14       | M2 | MA  | (1) | 3    | NONE     | "B" LABEL              | R-139A                        | PR 2'-0" x 8'-4 1/2" x 1 3/4"  | 9                                 | W23   | WG  | —         | 24       | NONE     | SEE (1)  | R-214C                      | PR 1'-6" x 7'-0 1/2" x 1 3/8"     | 1                                 | W13 SM | WD    | —     | 40  | NONE     | SEE (1)  |                           |                   |  |  |  |  |  |  |
| R-5       | 2'-4"                         | x 7'-2 1/2" x 13'-6" | 14       | M5 | MA  | (1) | 8    | NONE     | 16" X 4" GRILLE        | R-139B                        | PR 2'-0" x 8'-4 1/2" x 1 3/4"  | 9                                 | W23   | WG  | —         | 26       | 1/2" ASL | SEE (1)  | R-215                       | 2'-6" x 7'-0 1/2" x 1 3/8"        | 9                                 | W14    | WH    | (1)   | 27  | 1/2" ASL | SEE (1)  |                           |                   |  |  |  |  |  |  |
| R-6       | 2'-4"                         | x 7'-2 1/2" x 13'-6" | 14       | M5 | MA  | (1) | 10   | NONE     | 16" X 4" GRILLE        | R-139C                        | PR 2'-0" x 8'-4 1/2" x 1 3/4"  | 9                                 | W23   | WG  | —         | 26       | 1/2" ASL | SEE (1)  | R-216                       | PR 1'-6" x 7'-0 1/2" x 1 3/8"     | 1                                 | W13 SM | WD    | —     | 40  | NONE     | SEE (1)  |                           |                   |  |  |  |  |  |  |
| R-7A      | 2'-8"                         | x 7'-2 1/2" x 13'-6" | 14       | M5 | MA  | (1) | 2    | NONE     | "B" LABEL              | R-139D                        | PR 2'-0" x 8'-4 1/2" x 1 3/4"  | 9                                 | W23   | WG  | —         | 26       | 1/2" ASL | SEE (1)  | R-217                       | 2'-6" x 7'-0 1/2" x 1 3/8"        | 8                                 | W1     | WJ    | WD    | 27  | NONE     | SEE (1)  |                           |                   |  |  |  |  |  |  |
| R-7B      | 3'-4"                         | x 7'-2 1/2" x 13'-6" | 14       | M5 | MA  | (1) | 1    | NONE     | "A" LABEL              | R-140A                        | PR 2'-0" x 8'-4 1/2" x 2 1/2"  | 9                                 | W23   | WG  | —         | 26       | 1/2" ASL | SEE (1)  | R-218                       | 2'-6" x 7'-0 1/2" x 1 3/8"        | 9                                 | W14    | WH    | (1)   | 27  | 1/2" ASL | SEE (1)  |                           |                   |  |  |  |  |  |  |
| R-8A      | 3'-4"                         | x 7'-2 1/2" x 13'-6" | 14       | M5 | MA  | (1) | 6    | NONE     |                        | R-140B                        | PR 2'-0" x 8'-4 1/2" x 2 1/2"  | 9                                 | W23   | WG  | —         | 26       | 1/2" ASL | SEE (1)  | R-219                       | PR 2'-6" x 7'-0 1/2" x 1 3/8"     | 8                                 | W1     | WJ    | WD    | 27  | NONE     | SEE (1)  |                           |                   |  |  |  |  |  |  |
| R-8B      | 3'-0"                         | x 7'-2 1/2" x 13'-6" | 14       | M5 | MA  | (1) | 6    | NONE     |                        | R-140C                        | PR 2'-0" x 8'-4 1/2" x 2 1/2"  | 9                                 | W23   | WG  | —         | 26       | 1/2" ASL | SEE (1)  | R-220                       | PR 2'-6" x 7'-0 1/2" x 1 3/8"     | 1                                 | W5-W6  | WD    | (1)   | 51  | 1/2" ASL | SEE (1)  | 1/2" OBS. GLASS SIDELIGHT |                   |  |  |  |  |  |  |
| R-9       | 3'-4"                         | x 7'-2 1/2" x 13'-6" | 14       | M1 | MA  | (1) | 1    | NONE     | "A" LABEL              | R-140D                        | PR 2'-0" x 8'-4 1/2" x 2 1/2"  | 9                                 | W23   | WG  | —         | 26       | 1/2" ASL | SEE (1)  | R-221                       | 2'-6" x 7'-0 1/2" x 1 3/8"        | 9                                 | W10    | WH    | (1)   | 25  | 1/2" ASL | SEE (1)  |                           |                   |  |  |  |  |  |  |
| R-10A     | 3'-0"                         | x 7'-2 1/2" x 13'-6" | 14       | M5 | MA  | (1) | 1    | NONE     | "A" LABEL              | R-141A                        | PR 2'-0" x 11'-4 1/2" x 1 3/4" | 1                                 | W5-W6 | WA  | (1)       | 14       | NONE     | SEE (1)  | R-120D                      | PR 1'-8 1/2" x 5'-1 1/2" x 2 1/4" | 18                                | W4     | WL    | (1)   | 45  | 1/2" ASL | SEE (1)  |                           |                   |  |  |  |  |  |  |
| R-10B     | 3'-0"                         | x 7'-2 1/2" x 13'-6" | 14       | M5 | MA  | (1) | 2    | NONE     | "B" LABEL              | R-141B                        | PR 2'-0" x 11'-4 1/2" x 1 3/4" | 8                                 | W1    | WJ  | (1)       | 14       | NONE     | SEE (1)  | R-121E                      | PR 1'-8 1/2" x 5'-1 1/2" x 2 1/4" | 18                                | W4     | WL    | (1)   | 45  | 1/2" ASL | SEE (1)  |                           |                   |  |  |  |  |  |  |
| R-11A     | 3'-4"                         | x 7'-2 1/2" x 13'-6" | 14       | M5 | MA  | (1) | 1    | NONE     | "A" LABEL              | R-141C                        | PR 2'-0" x 8'-4 1/2" x 1 3/4"  | 9                                 | W10   | WH  | (1)       | 14       | 1/2" ASL | SEE (1)  |                             |                                   |                                   |        |       |       |     |          |          |                           |                   |  |  |  |  |  |  |
| R-11B     | PR 3'-0" x 7'-2 1/2" x 13'-6" | 14                   | M5       | MA | (1) | 7   | NONE |          | R-141D                 | PR 2'-0" x 8'-4 1/2" x 2 1/2" | 9                              | W10                               | WH    | (1) | 14        | 1/2" ASL | SEE (1)  |          |                             |                                   |                                   |        |       |       |     |          |          |                           |                   |  |  |  |  |  |  |
| R-12A     | 3'-10"                        | x 8'-0" x 13'-6"     | 14       | M1 | MA  | (1) | 9    | 1/2" ASL | SEE (1)                | R-145                         | 2'-0" x 8'-4 1/2" x 1 3/4"     | 9                                 | W10   | WH  | (1)       | 14       | 1/2" ASL | SEE (1)  |                             |                                   |                                   |        |       |       |     |          |          |                           |                   |  |  |  |  |  |  |
| R-13B     | 2'-9"                         | x 8'-0" x 13'-6"     | 16       | M1 | MA  | (1) | 9    | 1/2" ASL | SEE (1)                | R-146                         | 2'-0" x 8'-4 1/2" x 1 3/4"     | 9                                 | W10   | WH  | (1)       | 14       | 1/2" ASL | SEE (1)  |                             |                                   |                                   |        |       |       |     |          |          |                           |                   |  |  |  |  |  |  |
| R-14      | 3'-0"                         | x 7'-2 1/2" x 13'-6" | 14       | M2 | MA  | (1) | 6    | NONE     | 20" X 8" GRILLE        | R-147A                        | PR 2'-0" x 11'-4 1/2" x 1 3/4" | 1                                 | W5-W6 | WD  | (1)       | 50       | NONE     | SEE (1)  |                             |                                   |                                   |        |       |       |     |          |          |                           |                   |  |  |  |  |  |  |
| R-15      | 3'-0"                         | x 7'-2 1/2" x 13'-6" | 14       | M2 | MA  | (1) | 6    | NONE     | 20" X 6" GRILLE        | R-147B                        | PR 2'-0" x 8'-4 1/2" x 2 1/2"  | 5                                 | W7    | WA  | PANEL (B) | 37       | 1/2" ASL | SEE (1)  |                             |                                   |                                   |        |       |       |     |          |          |                           |                   |  |  |  |  |  |  |
| R-16      | 3'-0"                         | x 7'-2 1/2" x 13'-6" | 14       | M2 | MA  | (1) | 6    | NONE     | 20" X 6" GRILLE        |                               |                                | R-17A     | 3'-0"                         | x 7'-2 1/2" x 13'-6" | 14       | M2 | MA  | (1) | 6    | NONE     | 20" X 6" GRILLE        |                               |                                | R-17B     | 3'-0"                         | x 7'-2 1/2" x 13'-6" | 14       | M2 | MA  | (1) | 6    | NONE     | 20" X 6" GRILLE        |                               |                                | R-18      | 3'-4"                         | x 7'-2 1/2" x 13'-6" | 14       | M5 | MA  | (1) | 1    | NONE     | "A" LABEL              | R-148A                        | 3'-0 1/2" x 7'-0 1/2" x 1 3/4" | 1                                 | W5    | WB  | (1)       | 27       | 1/2" ASL | SEE (1)  |                             |                                   |                                   |        |       |       |     |          |          |                           |                   |  |  |  |  |  |  |
| R-19      | 2'-0"                         | x 7'-2 1/2" x 13'-6" | 14       | M2 | MA  | (1) | 8    | NONE     | 13" X 5" GRILLE        | R-148B                        | 2'-4 1/2" x 8'-4 1/2" x 1 3/4" | 1                                 | W5    | WA  | (1)       | 14       | NONE     | SEE (1)  |                             |                                   |                                   |        |       |       |     |          |          |                           |                   |  |  |  |  |  |  |
| R-20      | 2'-0"                         | x 7'-2 1/2" x 13'-6" | 14       | M2 | MA  | (1) | 10   | NONE     | 13" X 5" GRILLE        | R-149                         | 2'-4 1/2" x 7'-0 1/2" x 1 3/4" | 1                                 | W5    | WB  | (1)       | 27       | 1/2" ASL | SEE (1)  |                             |                                   |                                   |        |       |       |     |          |          |                           |                   |  |  |  |  |  |  |
| R-21A     | 3'-4"                         | x 7'-2 1/2" x 13'-6" | 14       | M5 | MA  | (1) | 1    | NONE     | "A" LABEL SEE (1)      | R-150                         | 2'-4 1/2" x 7'-0 1/2" x 1 3/4" | 1                                 | W9    | WA  | (1)       | 27       | 1/2" ASL | SEE (1)  |                             |                                   |                                   |        |       |       |     |          |          |                           |                   |  |  |  |  |  |  |
| R-21B     | 3'-4"                         | x 7'-2 1/2" x 13'-6" | 14       | M1 | MD  | (1) | 4    | NONE     | "B" LABEL SEE (1)      | R-151                         | 2'-4 1/2" x 7'-0 1/2" x 1 3/4" | 1                                 | W5    | WB  | (1)       | 27       | 1/2" ASL | SEE (1)  |                             |                                   |                                   |        |       |       |     |          |          |                           |                   |  |  |  |  |  |  |
| R-21C     | 2'-4"                         | x 7'-2 1/2" x 13'-6" | 14       | M2 | MA  | (1) | 8    | NONE     |                        | R-152                         | 2'-4 1/2" x 7'-0 1/2" x 1 3/4" | 1                                 | W9    | WA  | (1)       | 27       | 1/2" ASL | SEE (1)  |                             |                                   |                                   |        |       |       |     |          |          |                           |                   |  |  |  |  |  |  |
| R-21A     | 3'-4"                         | x 7'-2 1/2" x 13'-6" | 14       | M1 | MA  | (1) | 3    | NONE     | "B" LABEL              | R-154                         | 2'-4 1/2" x 7'-0 1/2" x 1 3/4" | 1                                 | W5    | WB  | (1)       | 27       | 1/2" ASL | SEE (1)  |                             |                                   |                                   |        |       |       |     |          |          |                           |                   |  |  |  |  |  |  |
| R-21B     | 3'-4"                         | x 7'-2 1/2" x 13'-6" | 14       | M5 | MA  | (1) | 2    | NONE     |                        | R-155A                        | 3'-0 1/2" x 7'-0 1/2" x 1 3/4" | 1                                 | W5    | WB  | (1)       | 27       | 1/2" ASL | SEE (1)  |                             |                                   |                                   |        |       |       |     |          |          |                           |                   |  |  |  |  |  |  |
| R-21C     | 3'-0"                         | x 7'-2 1/2" x 13'-6" | 14       | M1 | MA  | (1) | 2    | NONE     | "B" LABEL              | R-155B                        | 2'-0" x 8'-4 1/2" x 2 1/2"     | 5                                 | W7    | WA  | PANEL (E) | 37       | 1/2" ASL | SEE (1)  |                             |                                   |                                   |        |       |       |     |          |          |                           |                   |  |  |  |  |  |  |
| R-21A     | 3'-4"                         | x 7'-2 1/2" x 13'-6" | 14       | M5 | MA  | (1) | 2    | NONE     |                        | R-156C                        | 2'-4 1/2" x 8'-4 1/2" x 1 3/4" | 1                                 | W5    | WA  | (1)       | 14       | NONE     | SEE (1)  |                             |                                   |                                   |        |       |       |     |          |          |                           |                   |  |  |  |  |  |  |
| R-21B     | 3'-4"                         | x 7'-2 1/2" x 13'-6" | 14       | M2 | MC  | (1) | 2    | NONE     | "B" LABEL CONSTRUCTION | R-156A                        | 2'-4 1/2" x 7'-0 1/2" x 1 3/4" | 1                                 | W1    | WB  | (1)       | 25       | 1/2" ASL | SEE (1)  |                             |                                   |                                   |        |       |       |     |          |          |                           |                   |  |  |  |  |  |  |
| R-21C     | 3'-4"                         | x 7'-2 1/2" x 13'-6" | 14       | M2 | MA  | (1) | 3    | NONE     |                        | R-156B                        | 2'-5 1/2" x 7'-0 1/2" x 1 3/4" | 1                                 | W1    | WB  | (1)       | 25       | 1/2" ASL | SEE (1)  |                             |                                   |                                   |        |       |       |     |          |          |                           |                   |  |  |  |  |  |  |
| R-21B     | 3'-4"                         | x 7'-2 1/2" x 13'-6" | 14       | M1 | MA  | (1) | 1    | NONE     | "A" LABEL              | R-157                         | 2'-0" x 8'-4 1/2" x 2 1/2"     | 5                                 | W7    | WA  | PANEL (E) | 37       | 1/2" ASL | SEE (1)  |                             |                                   |                                   |        |       |       |     |          |          |                           |                   |  |  |  |  |  |  |
| R-21C     | 3'-4"                         | x 7'-2 1/2" x 13'-6" | 14       | M1 | MA  | (1) | 12   | 1/2" ASL | SEE (1)                | R-158                         | 2'-0" x 8'-4 1/2" x 1 3/4"     | 3                                 | W16   | WA  | (1)       | 14       | 1/2" ASL | SEE (1)  |                             |                                   |                                   |        |       |       |     |          |          |                           |                   |  |  |  |  |  |  |
| R-21D     | 3'-4"                         | x 7'-2 1/2" x 13'-6" | 14       | M1 | MA  | (1) | 12   | 1/2" ASL | SEE (1)                | R-159                         | 2'-0" x 8'-4 1/2" x 1 3/4"     | 3                                 | W16   | WA  | (1)       | 14       | 1/2" ASL | SEE (1)  |                             |                                   |                                   |        |       |       |     |          |          |                           |                   |  |  |  |  |  |  |
| R-21E     | 3'-4"                         | x 7'-2 1/2" x 13'-6" | 14       | M1 | MA  | (1) | 12   | 1/2" ASL | SEE (1)                | R-160                         | 2'-0" x 8'-4 1/2" x 1 3/4"     | 3                                 | W16   | WA  | (1)       | 14       | 1/2" ASL | SEE (1)  |                             |                                   |                                   |        |       |       |     |          |          |                           |                   |  |  |  |  |  |  |
| R-21F     | 3'-4"                         | x 7'-2 1/2" x 13'-6" | 14       | M1 | MA  | (1) | 12   | 1/2" ASL | SEE (1)                | R-161                         | 2'-0" x 8'-4 1/2" x 1 3/4"     | 3                                 | W16   | WA  | (1)       | 14       | 1/2" ASL | SEE (1)  |                             |                                   |                                   |        |       |       |     |          |          |                           |                   |  |  |  |  |  |  |
| R-21G     | 3'-4"                         | x 7'-2 1/2" x 13'-6" | 14       | M1 | MA  | (1) | 12   | 1/2" ASL | SEE (1)                | R-162                         | 2'-0" x 8'-4 1/2" x 1 3/4"     | 3                                 | W16   | WA  | (1)       | 14       | 1/2" ASL | SEE (1)  |                             |                                   |                                   |        |       |       |     |          |          |                           |                   |  |  |  |  |  |  |
| R-21H     | 3'-4"                         | x 7'-2 1/2" x 13'-6" | 14       | M1 | MA  | (1) | 12   | 1/2" ASL | SEE (1)                | R-163                         | 2'-0" x 8'-4 1/2" x 1 3/4"     | 3                                 | W16   | WA  | (1)       | 14       | 1/2" ASL | SEE (1)  |                             |                                   |                                   |        |       |       |     |          |          |                           |                   |  |  |  |  |  |  |

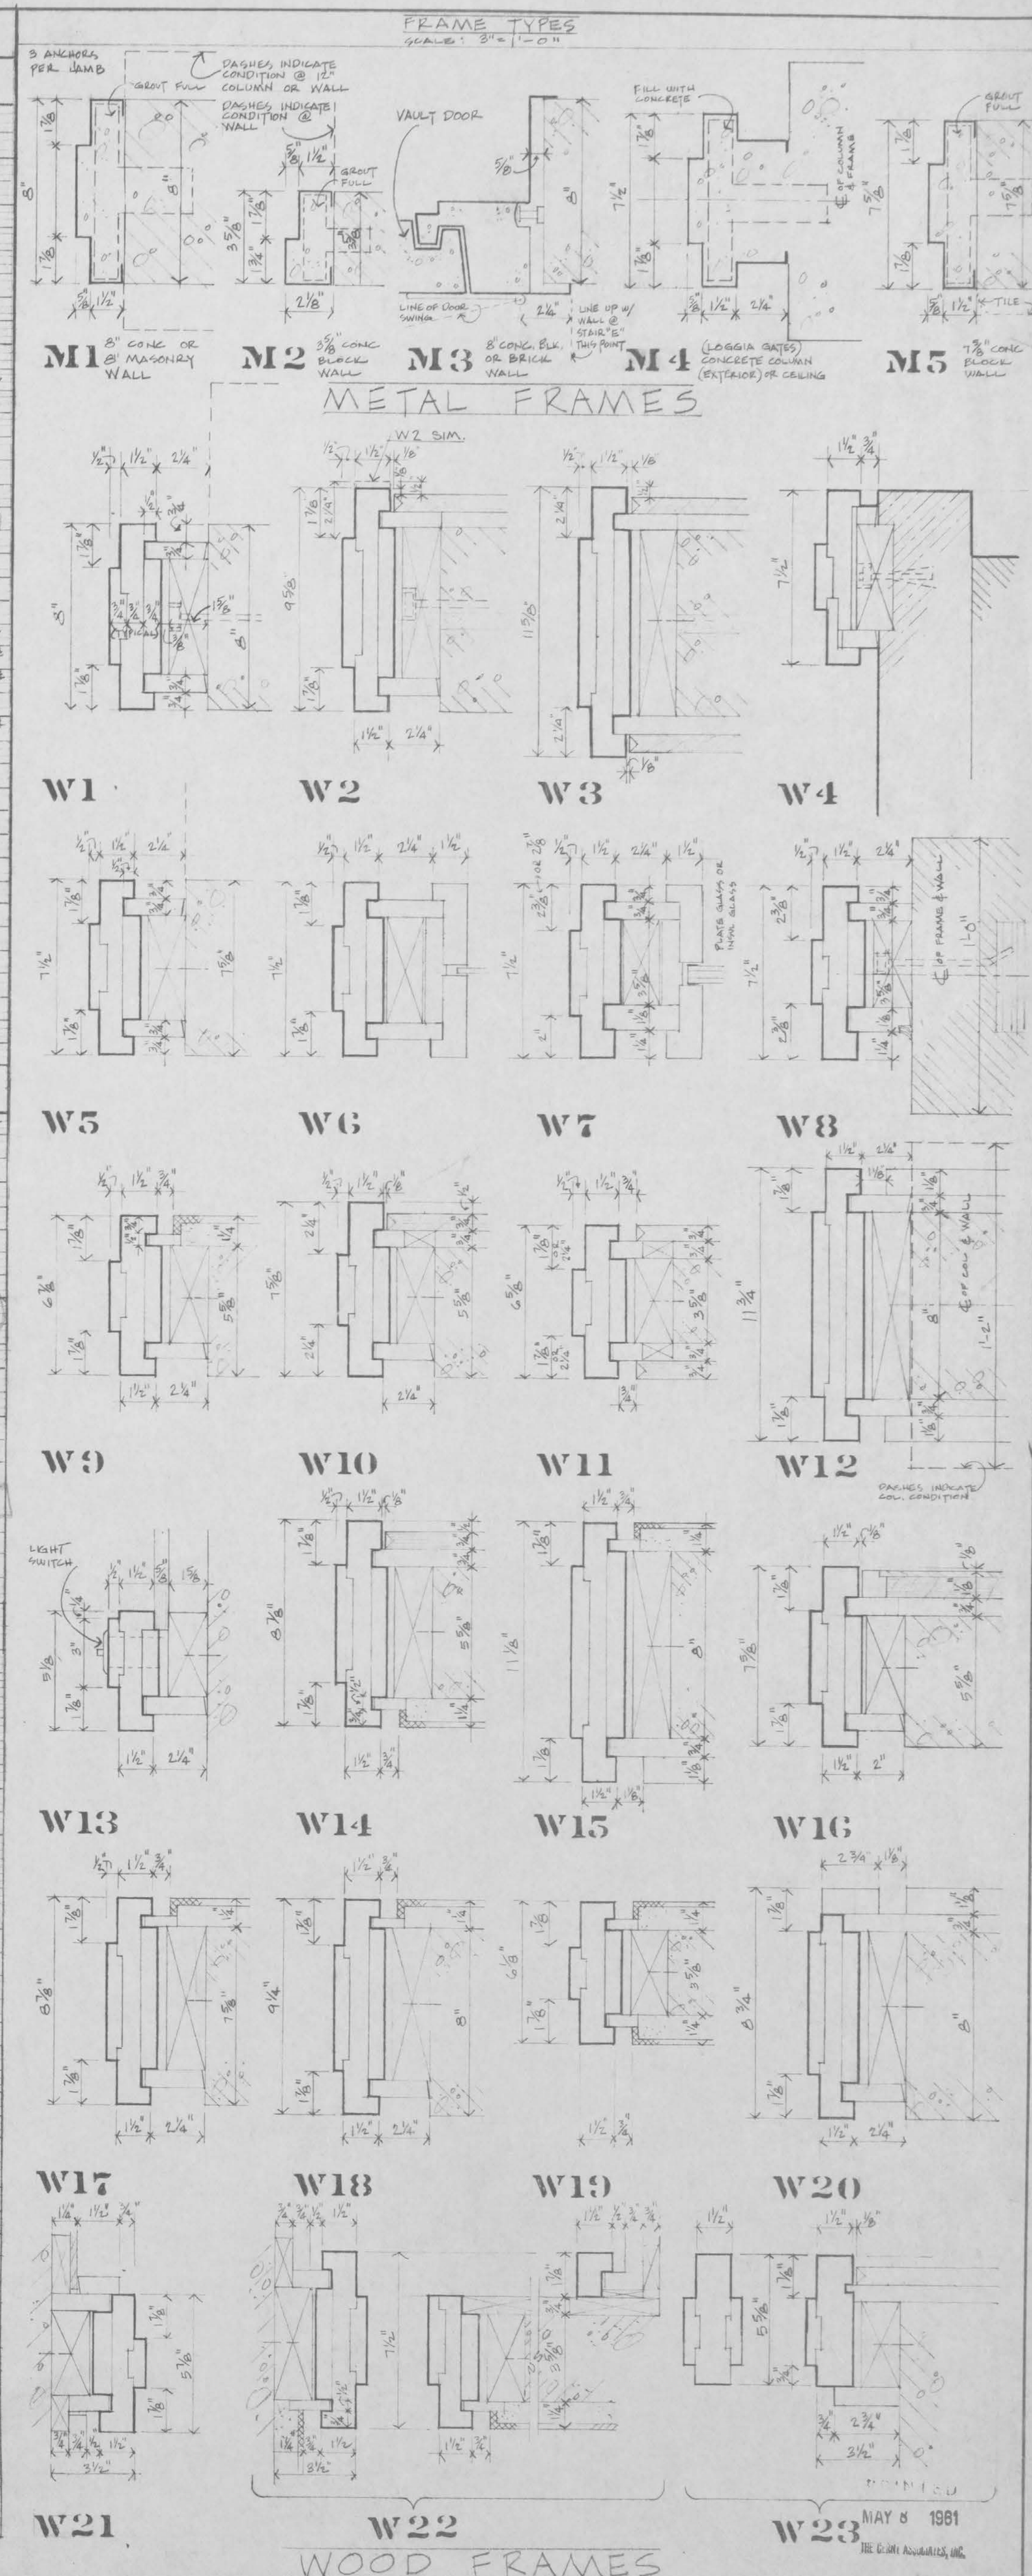

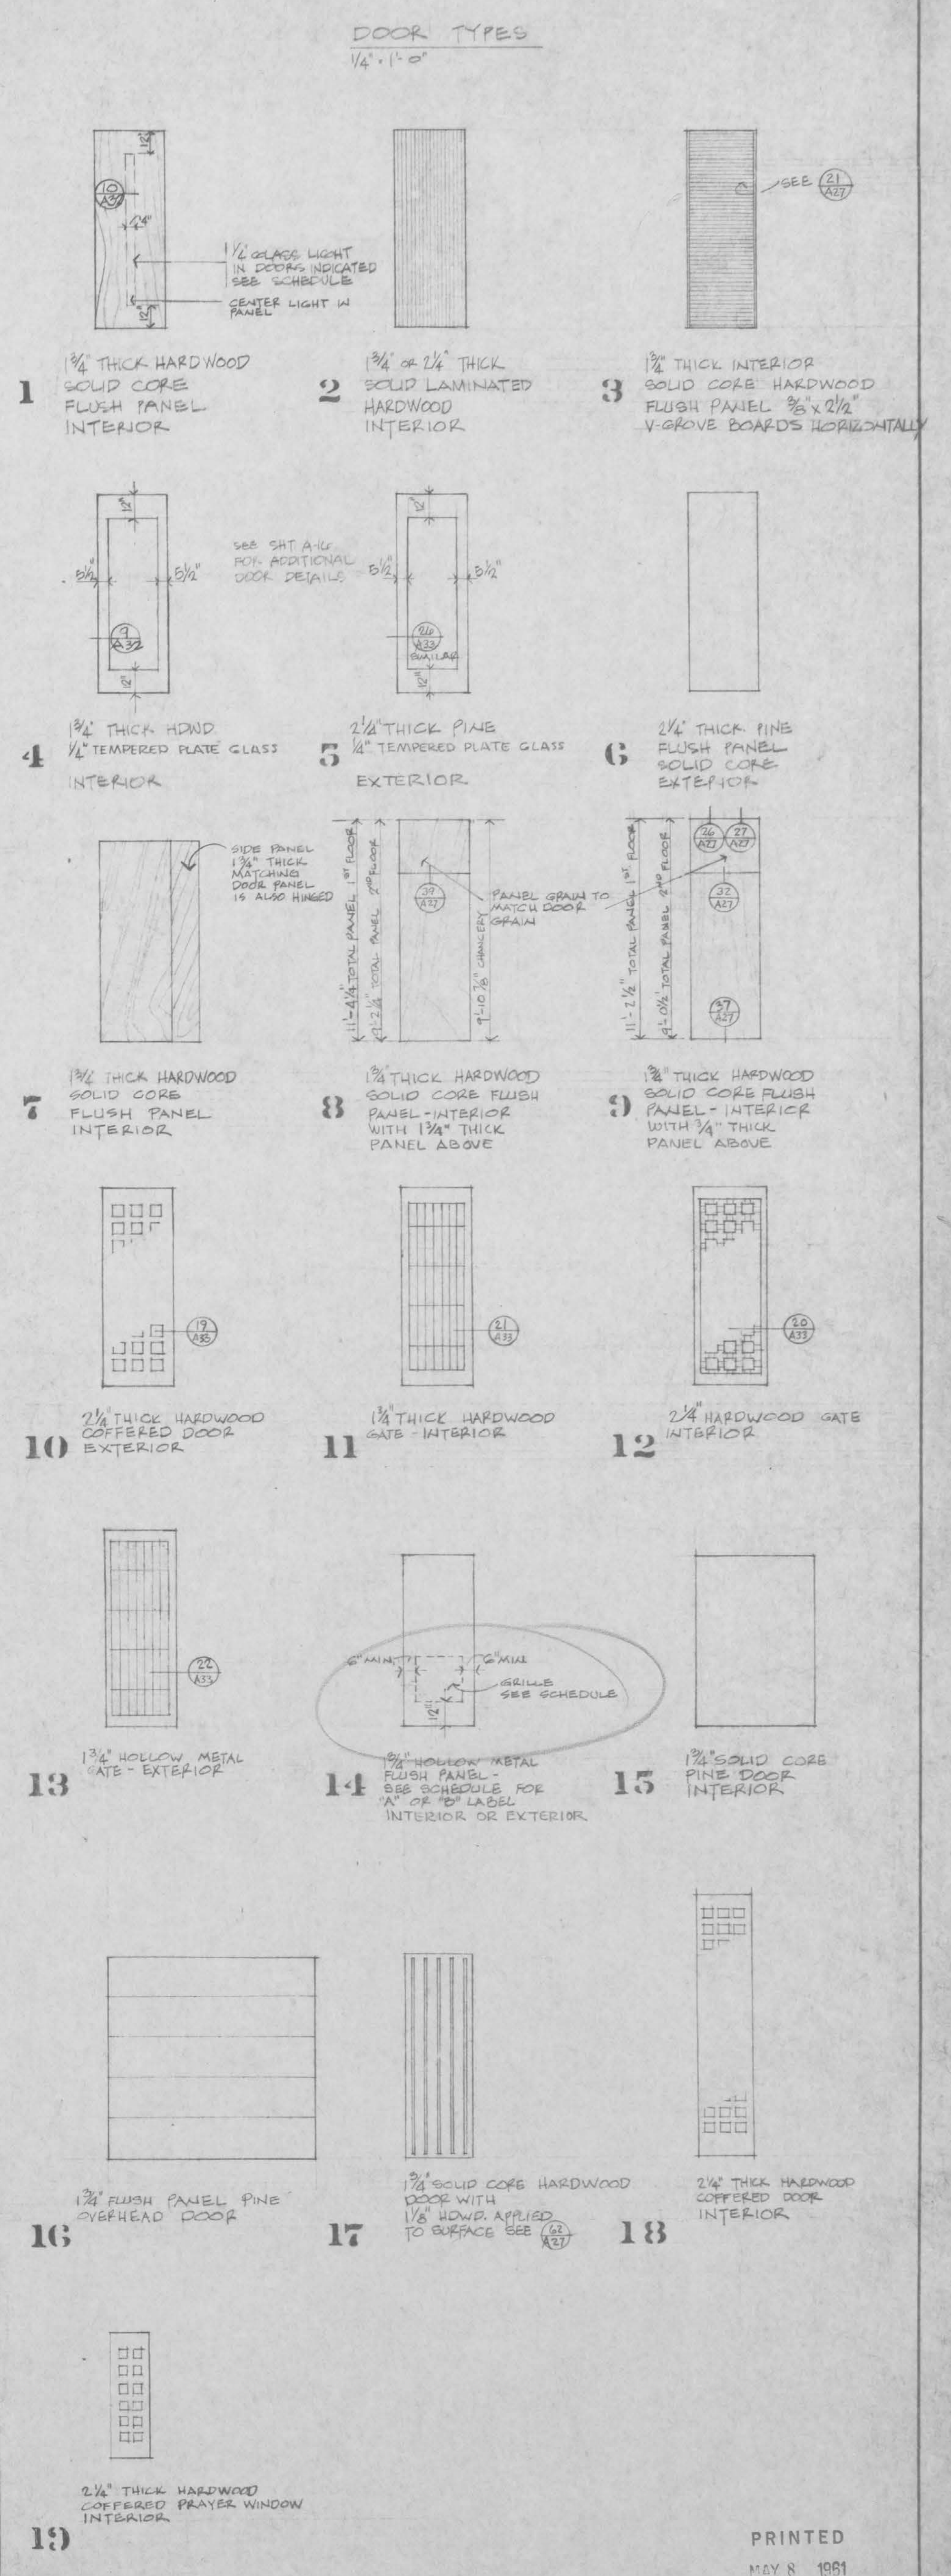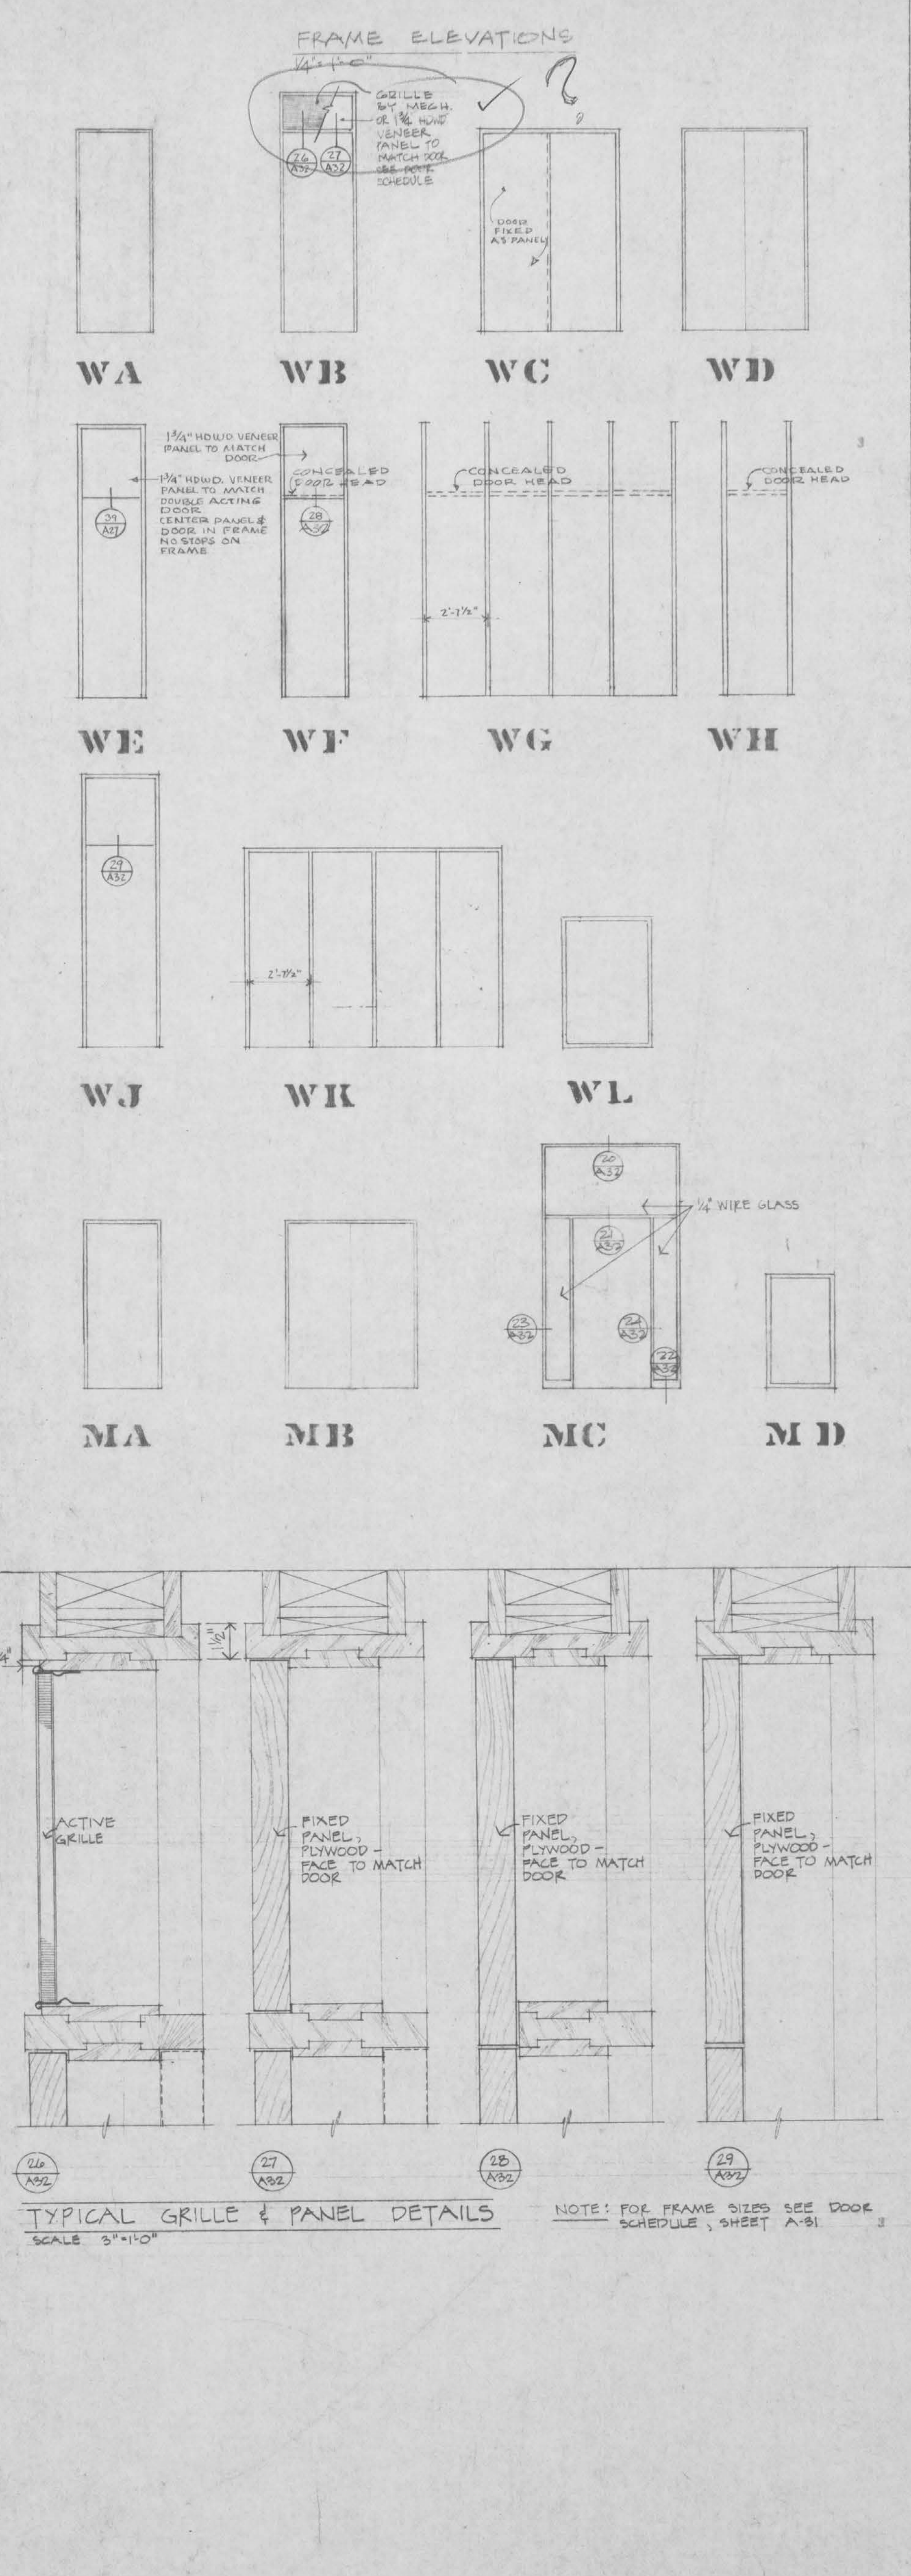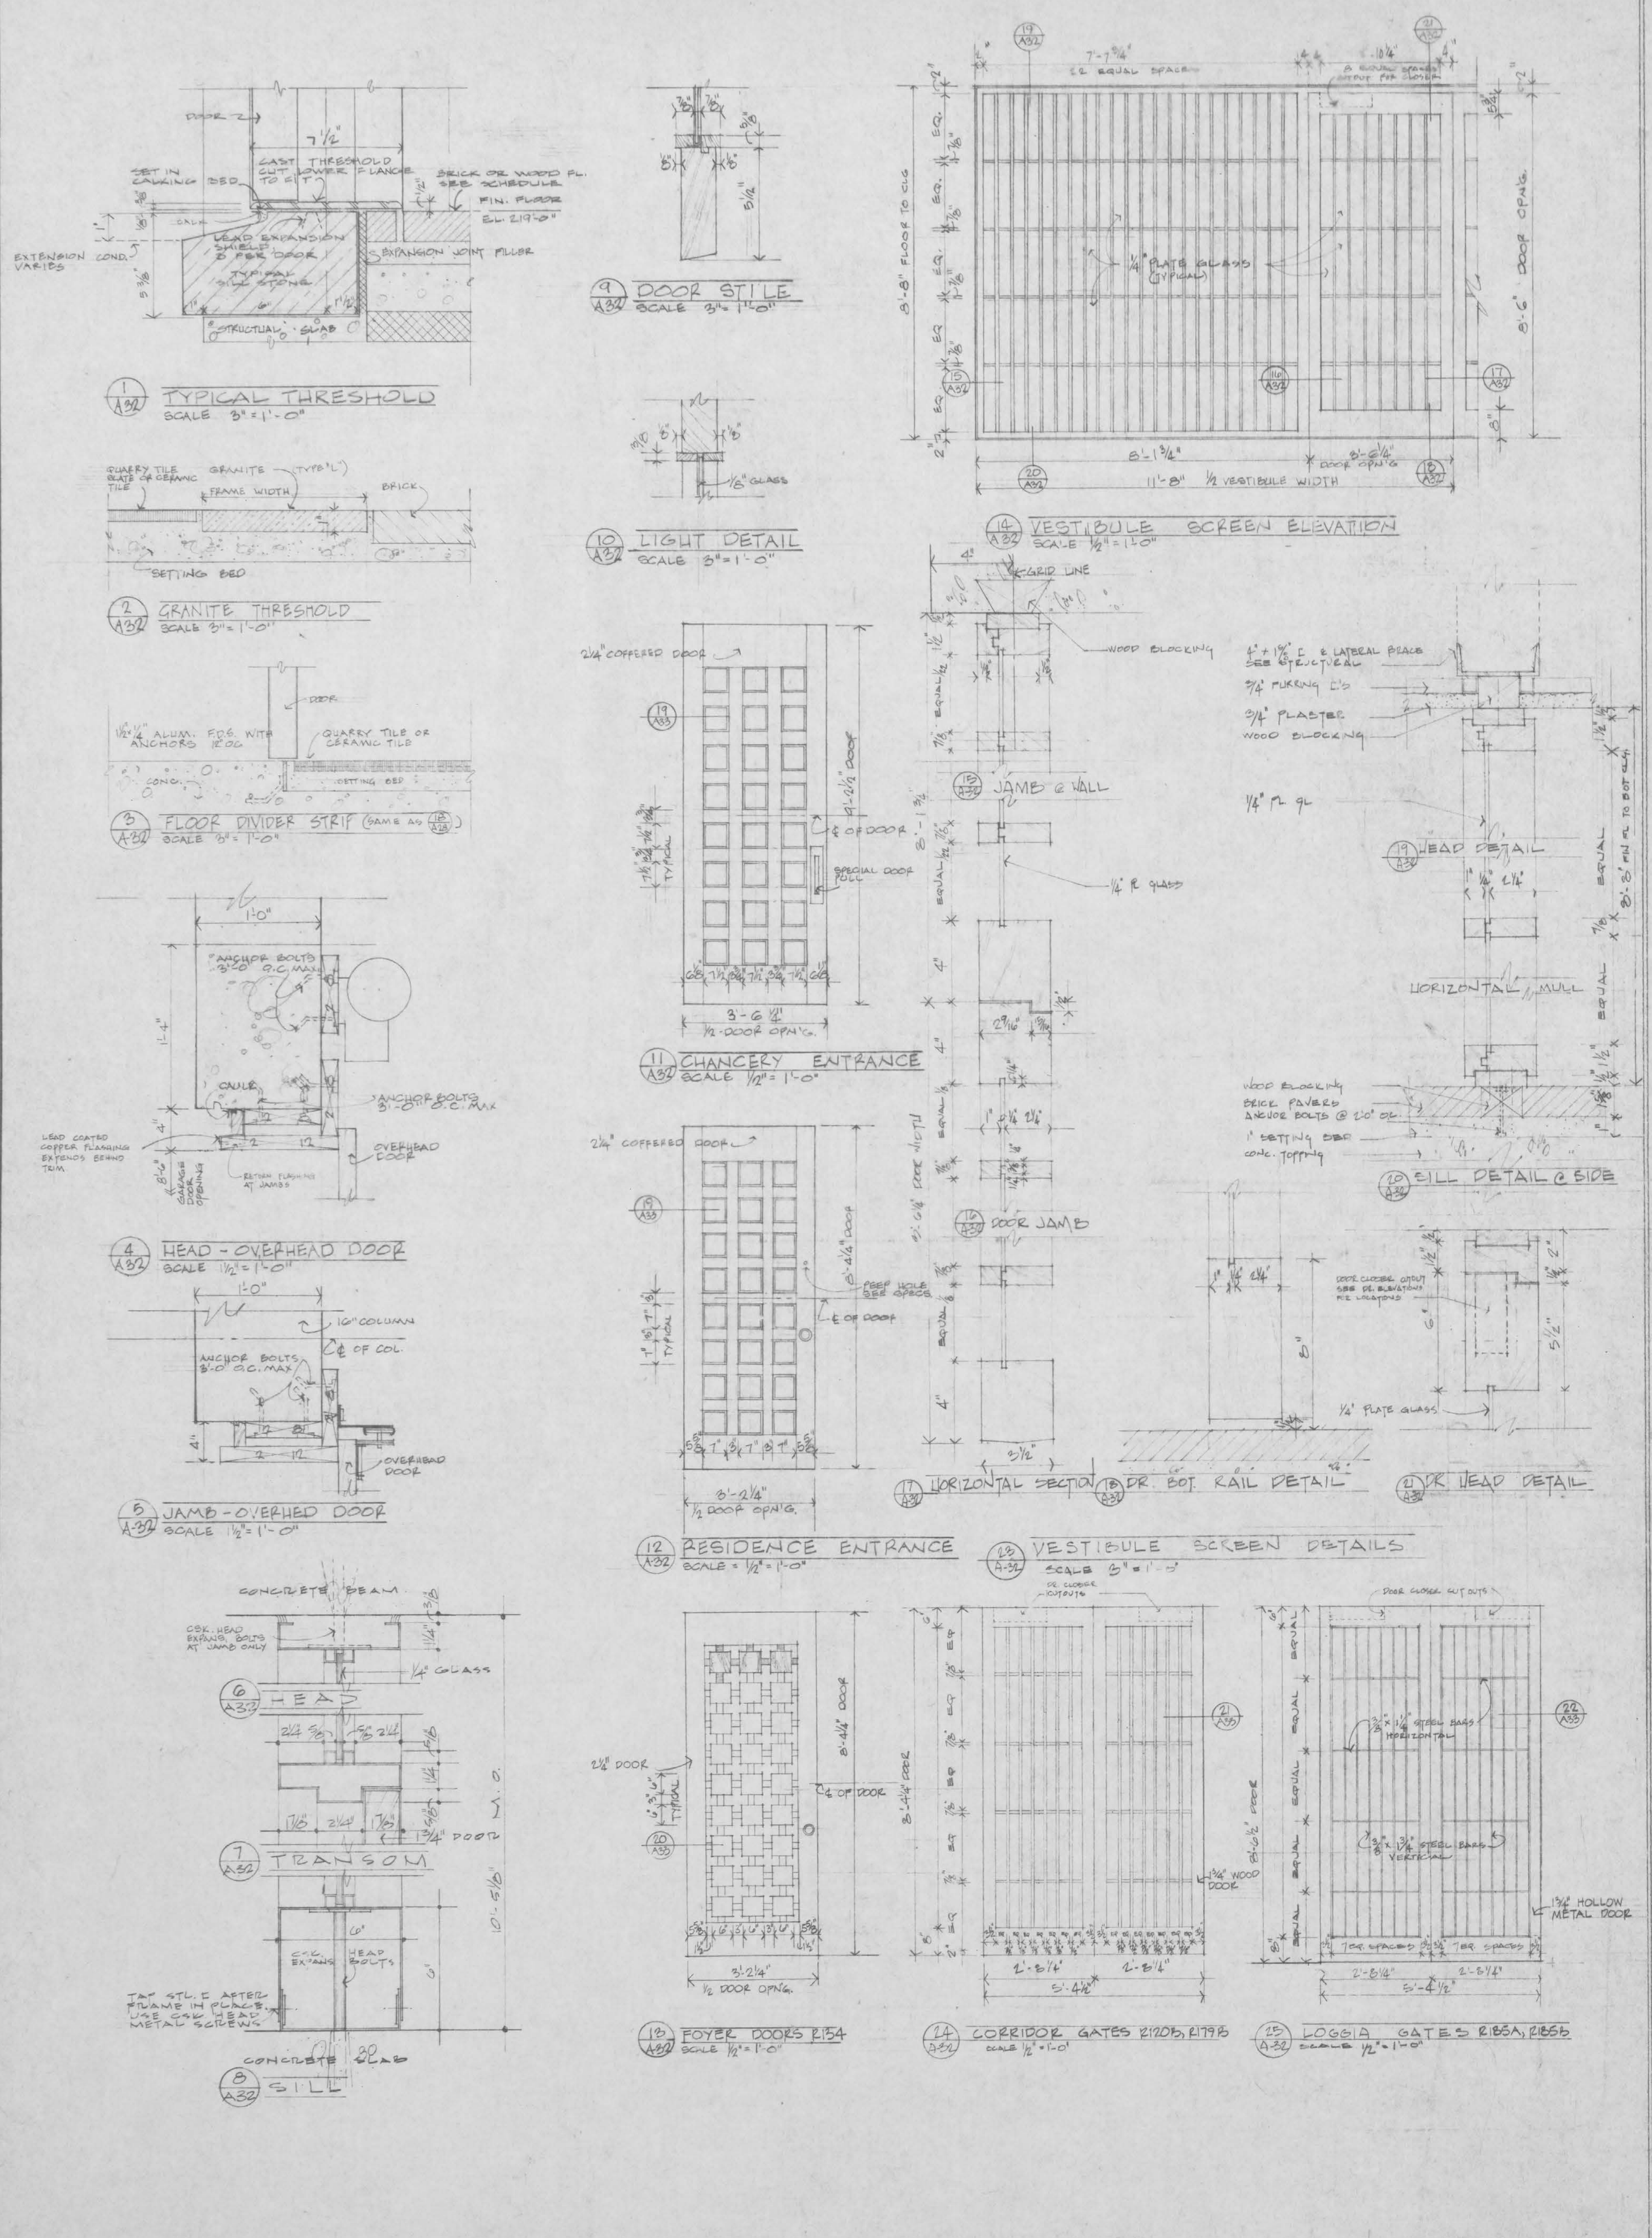


DATE FEB 15, 1961  
DRAWN RAQUEL  
CHECKED  
I HEREBY CERTIFY THAT THIS PLAN, SPECIFICATION, OR REPORT WAS PREPARED BY ME OR UNDER MY DIRECT SUPERVISION AND THAT I AM A DULY REGISTERED ARCHITECT OR ENGINEER UNDER THE LAWS OF THE STATE OF MINNESOTA.  
DATE FEB 15, 1961  
REG. NO. 1724  
REG. NO.

**THE CERNY ASSOCIATES inc.**  
architects | engineers | planners  
minneapolis • saint paul, minnesota


**CHANCERY AND RESIDENCE BUILDINGS  
FOR THE ARCHDIOCESE OF SAINT PAUL  
Saint Paul  
Minnesota**

**DOOR & DOOR  
FRAME DETAILS**  
SCALE: AS NOTED  
**A32**  
PROJECT NUMBER  
**37-00**

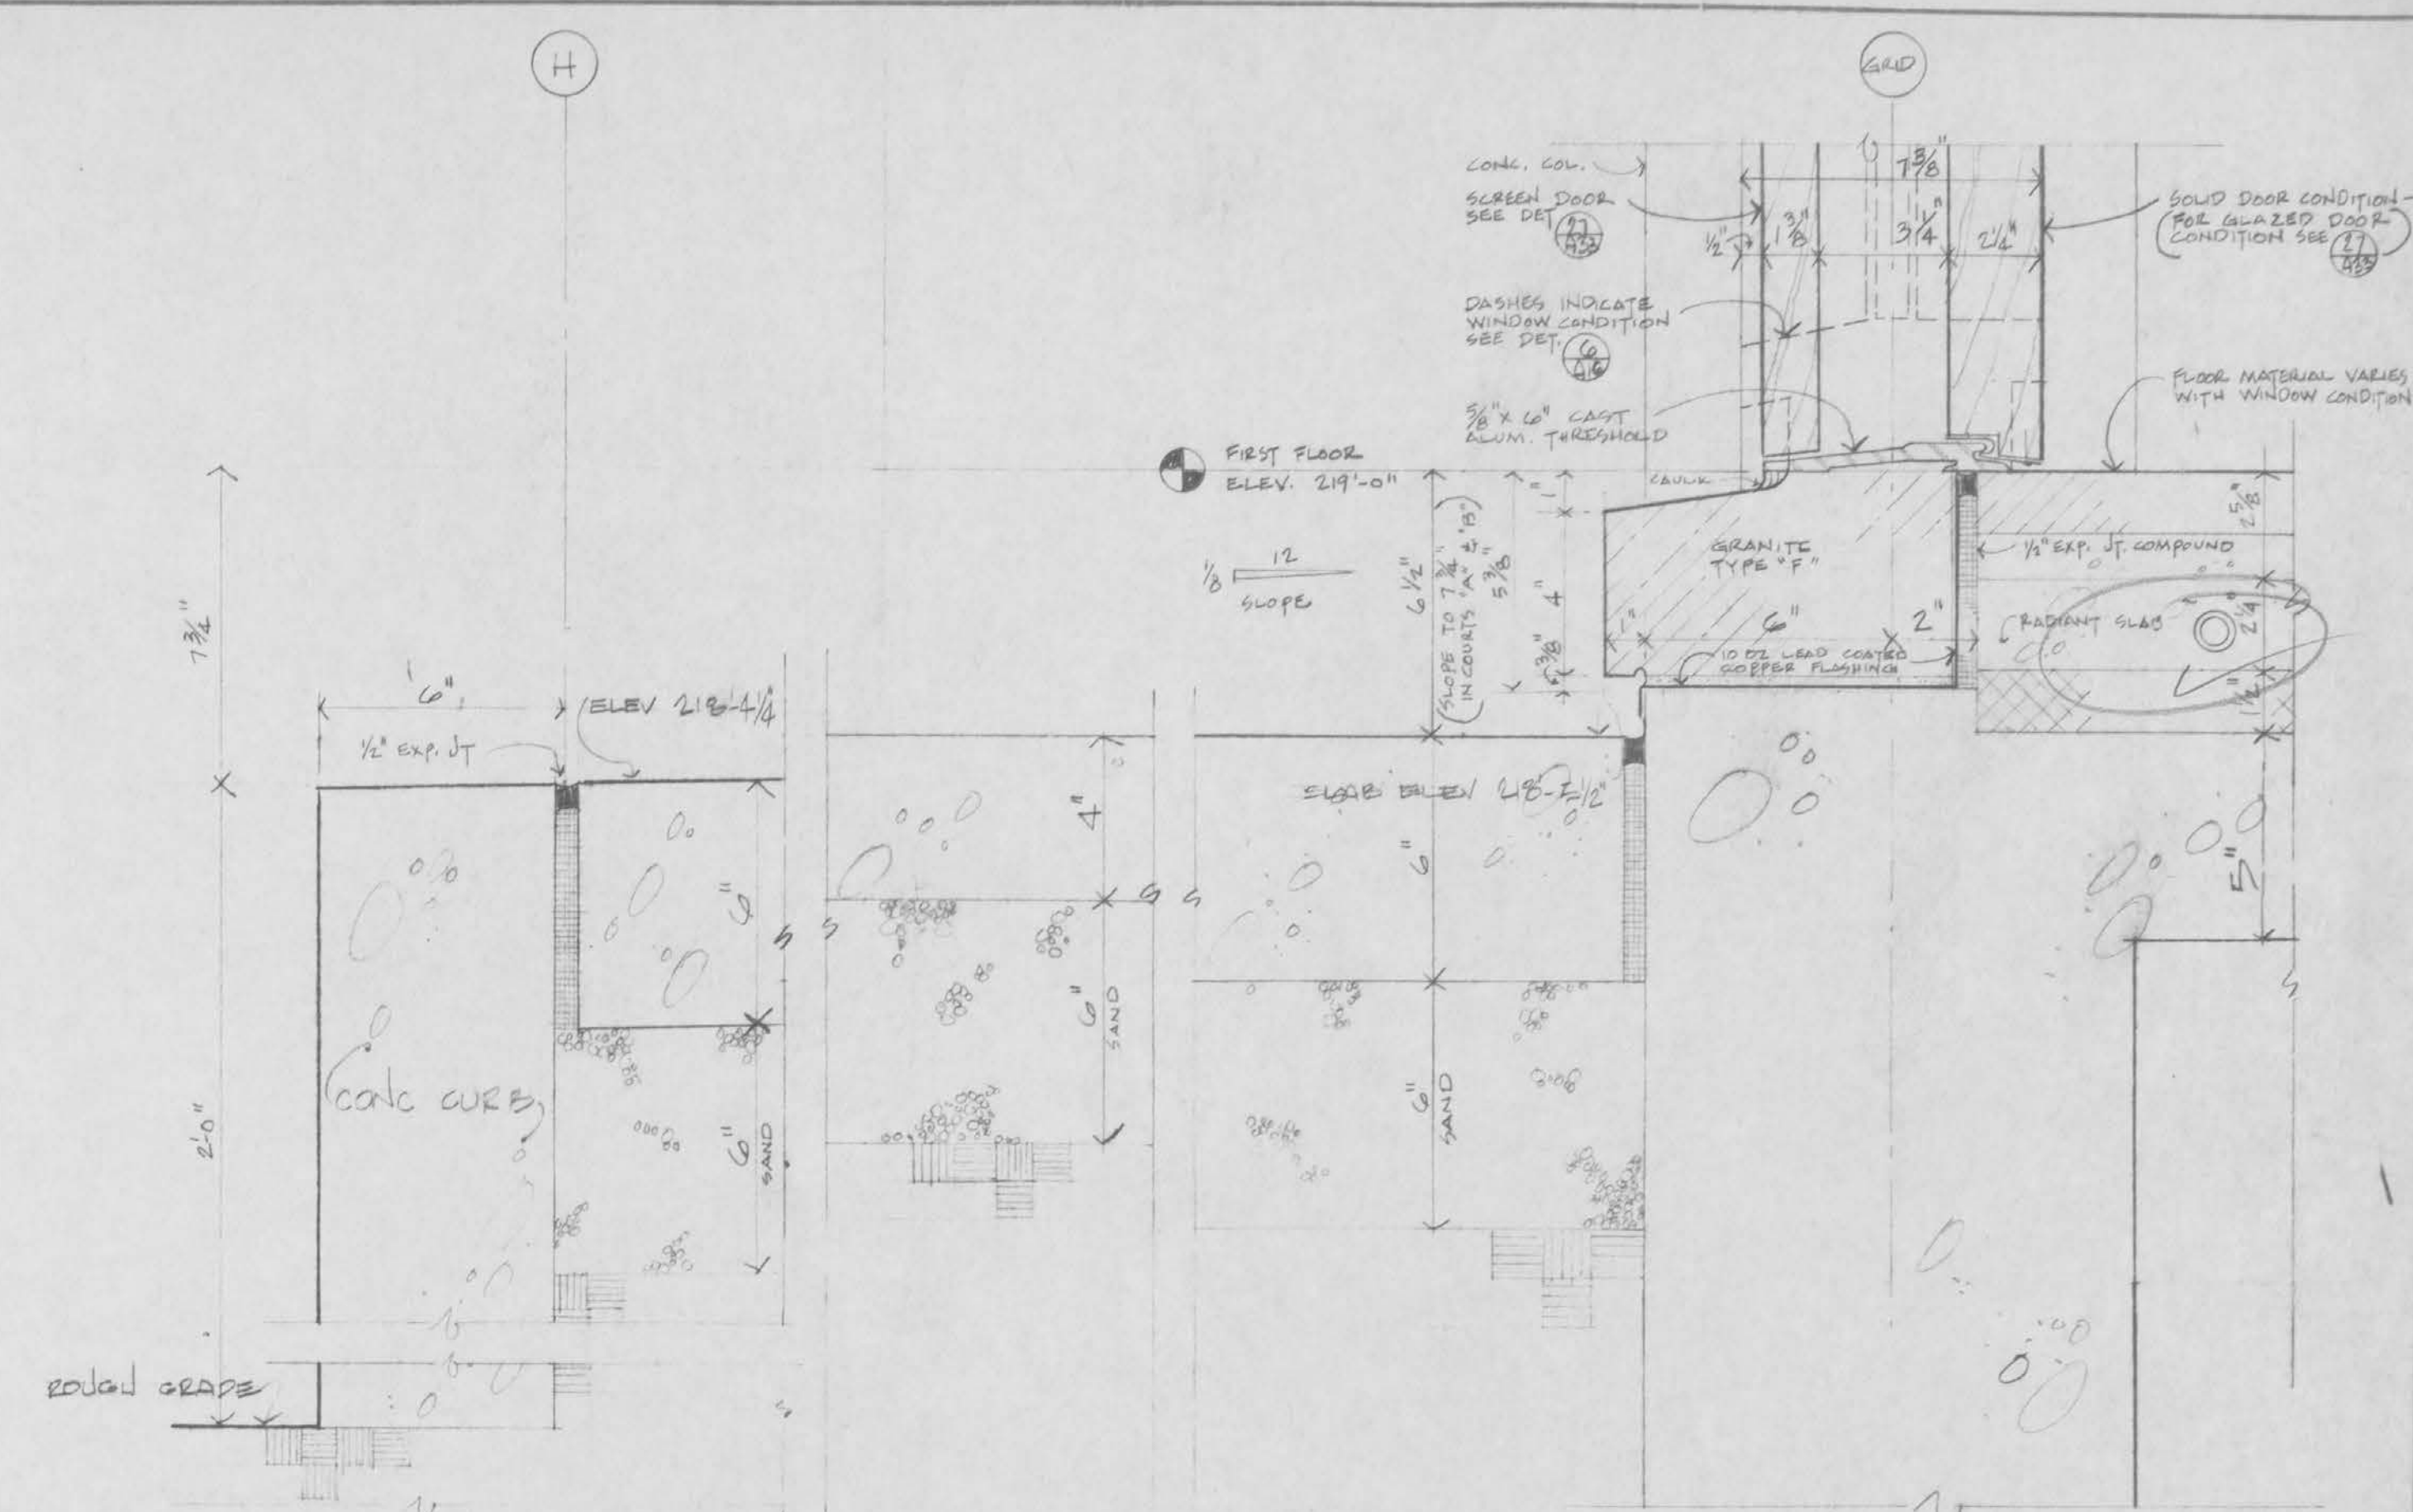


COURT SLAB @ WALL  
(EAST END OF WALLS)  
(COURTS "A" & "B")

⑧ STILL DETAIL - CORRIDOR  
TO COURTS "A" & "B"  
(STILL DETAIL OF  
WIN PANELS "Q" & "T"  
AT COURTS "C" & "D"  
SIMILAR)

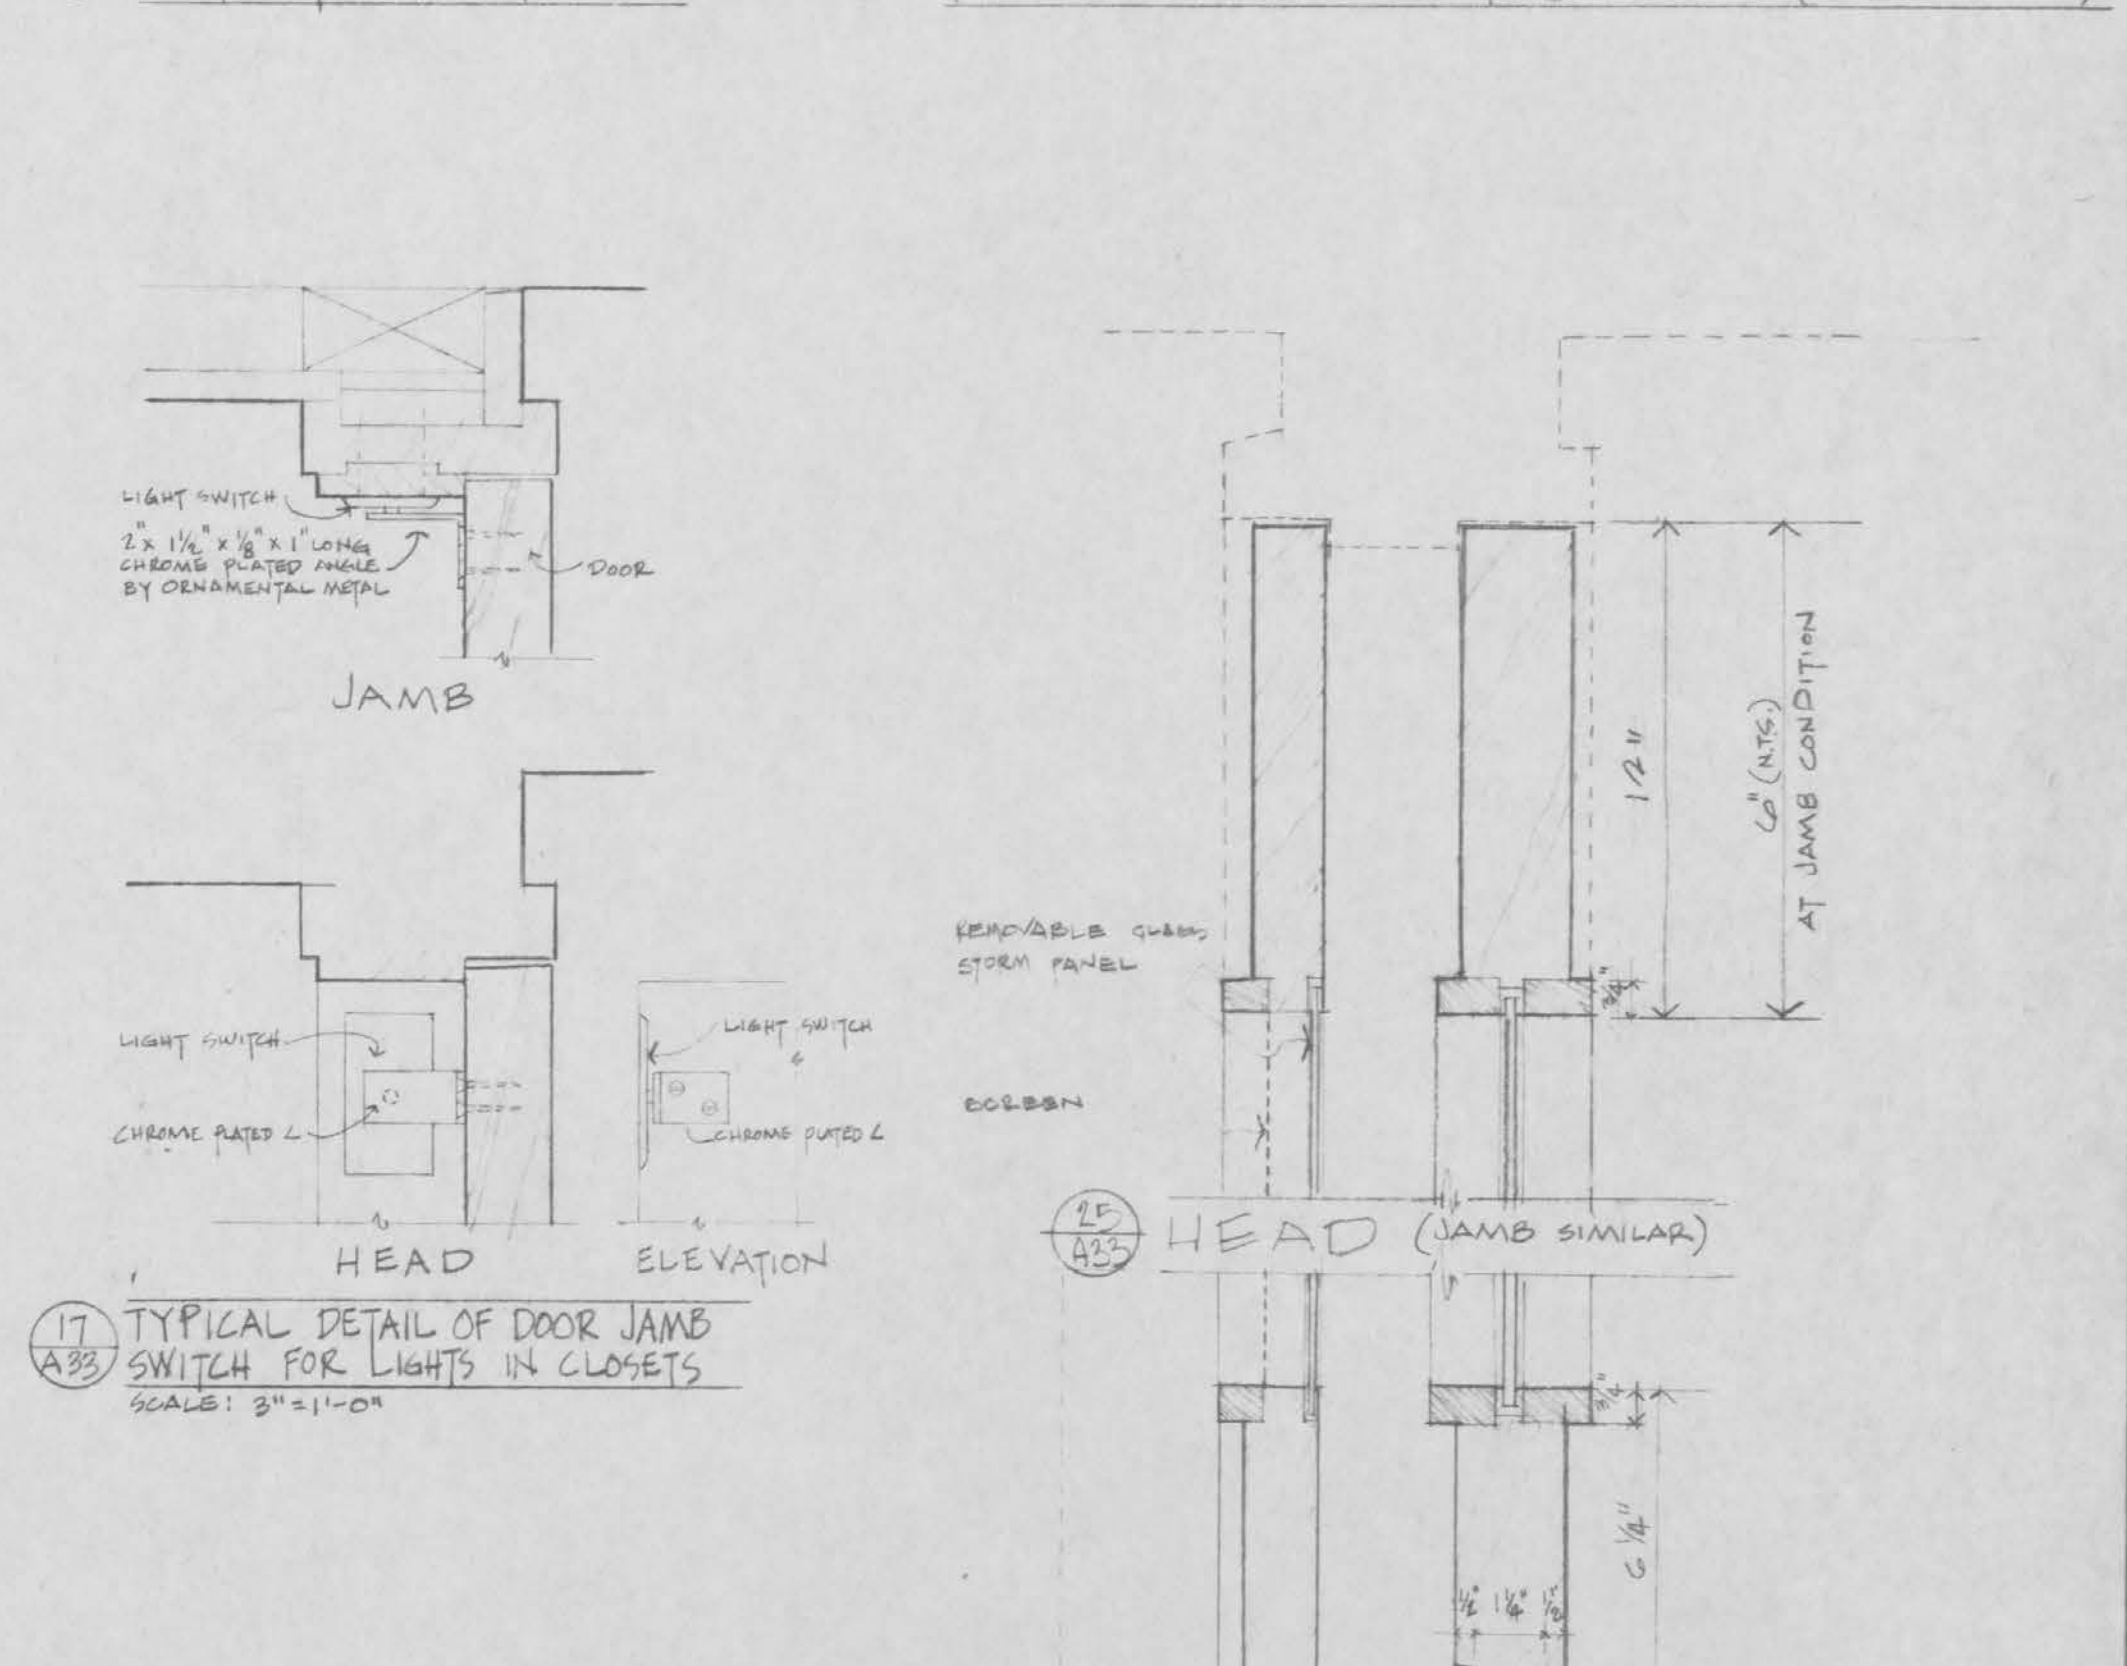

29 HEAD JAMB (TYPICAL @ CHAPEL DOORS  
A33 & PRAYER WINDOWS)

30 SILL (@ PRAYER WINDOWS)  
A33  $2' = 11.0"$

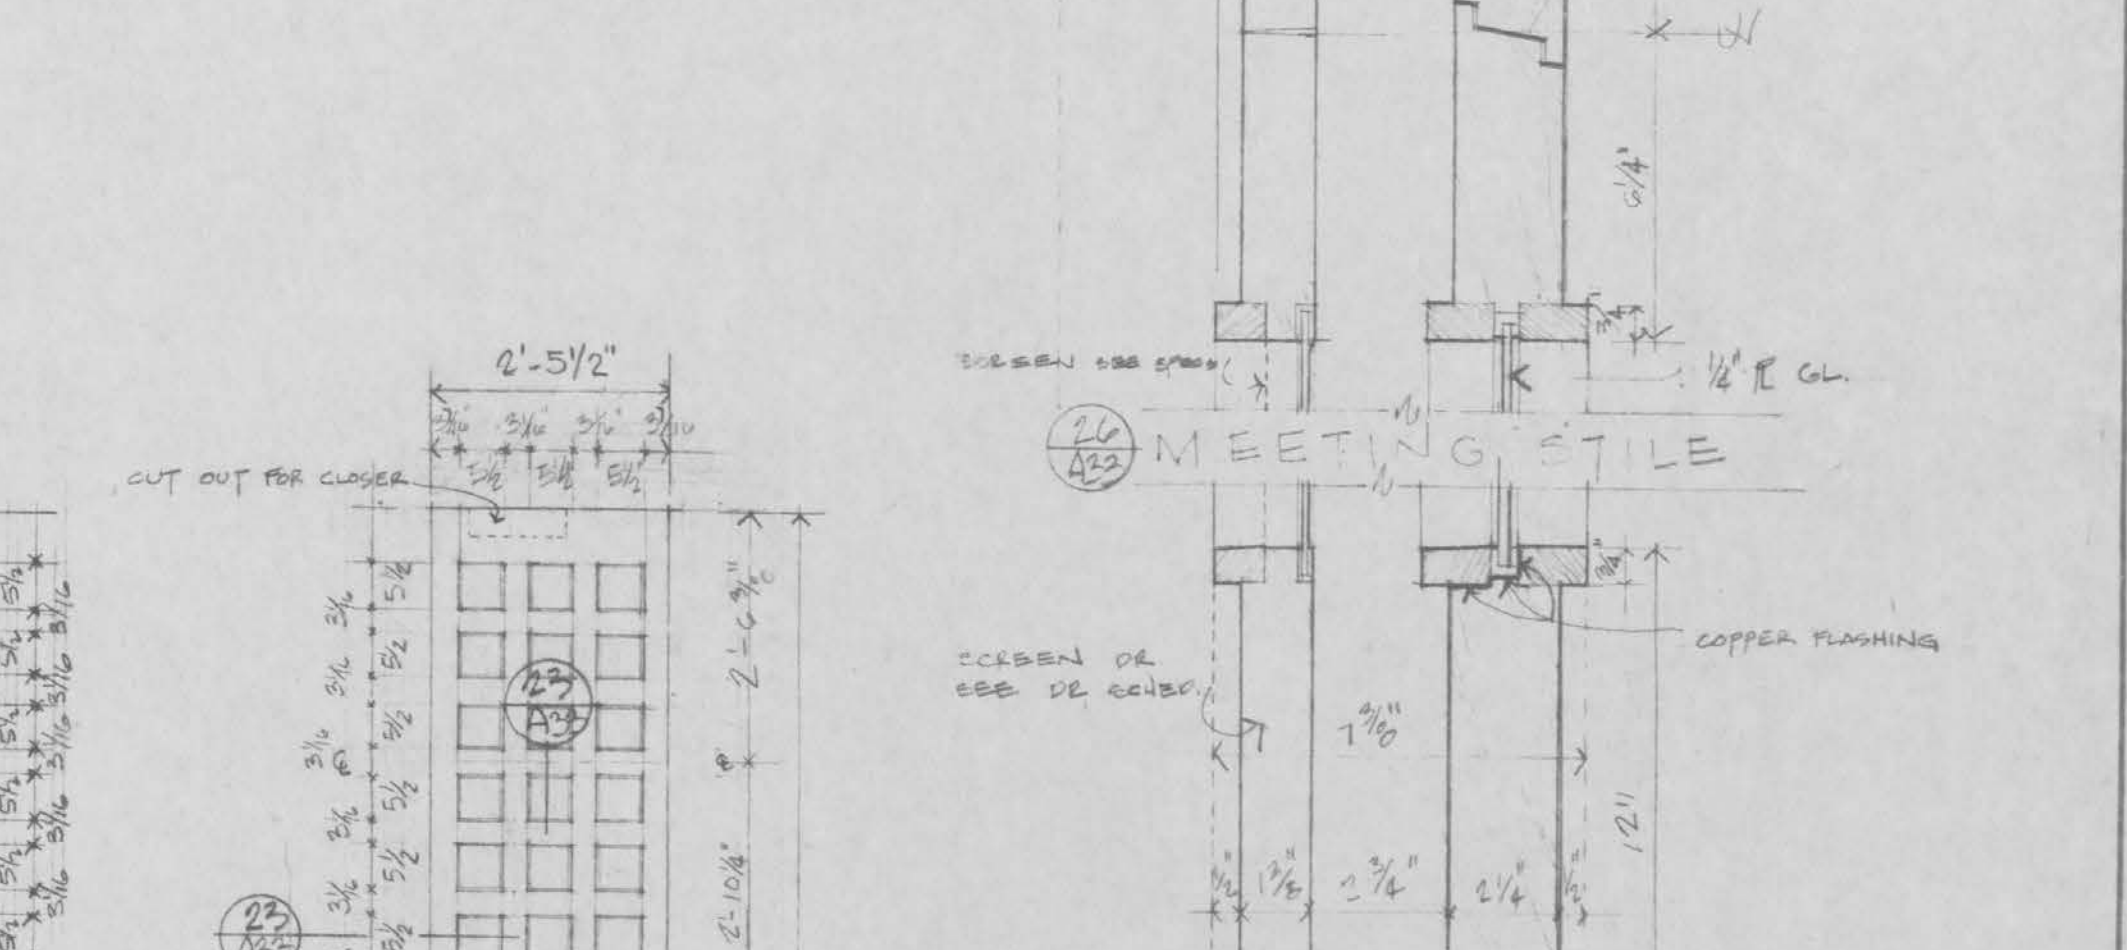

19 HORIZONTAL SECTION DETAIL  
A22 3" x 1'-0"

20  
A33

DETAIL OF STILE

3" = 1'-0"

28 PRAYER WINDS. ELEV.

23 DETAIL OF STU

2 1/4" HOMO COFFEE 250 0002

MEETING STILE

EXTERIOR GLAZED DOOR &  
COMBINATION DOOR DETAIL

2.2 TOP - RUNS CONTINUOUS ON EAST & SOUTH WALLS  
1'-0" 6'-0" @ TABLE 1'-0"

ELEVATION SECTION  
3/4" = 1'-0"  
MIMEOGRAPH ROOM CBE DETAILS

8 EXTERIOR HEAD & SILL DETAIL  
A33 3'-0"

23 DETAIL OF STU

2 1/4" HOMO COFFEE 250 0002

PRINT  
MAY 8

PRINTED  
MAY 8 1961  
THE CROWN ASSOCIATES, INC.

|                             |                                                                                                                                                                                                                     |
|-----------------------------|---------------------------------------------------------------------------------------------------------------------------------------------------------------------------------------------------------------------|
| DATE<br><b>FEB 15, 1961</b> | I HEREBY CERTIFY THAT THIS PLAN, SPECIFICATION, OR REPORT WAS PREPARED BY ME OR UNDER MY DIRECT SUPERVISION AND THAT I AM A DULY REGISTERED ARCHITECT OR ENGINEER UNDER THE LAWS OF THE STATE OF <b>NEB. E.C.A.</b> |
| DRAWN                       | DATE <b>FEB 15, 1961</b>                                                                                                                                                                                            |
| CHECKED                     | REG. No. <b>17564</b> <b>James G. Gentry</b>                                                                                                                                                                        |









**THE CERNY ASSOCIATES inc.**  
architects | engineers | planners  
minneapolis saint paul missoula


**CHANCERY AND RESIDENCE BUILDINGS  
FOR THE ARCHDIOCESE OF SAINT PAUL**  
**Saint Paul                                  Minnesota**


MILLWORK &  
MISCELLANEOUS DETAILS

SHEET NUMBER  
**A33**  
PROJECT NUMBER

SHEET NUMBER  
**A 33**  
PROJECT NUMBER

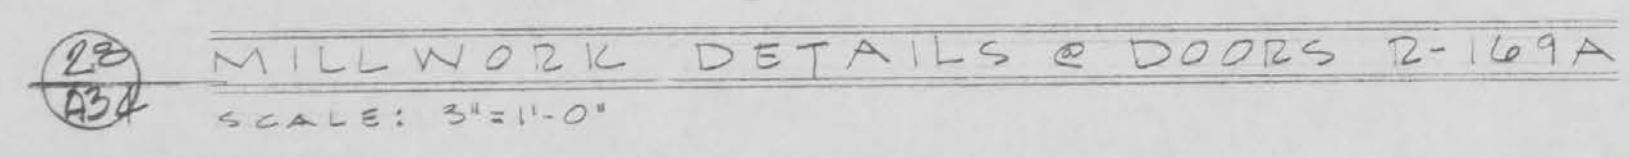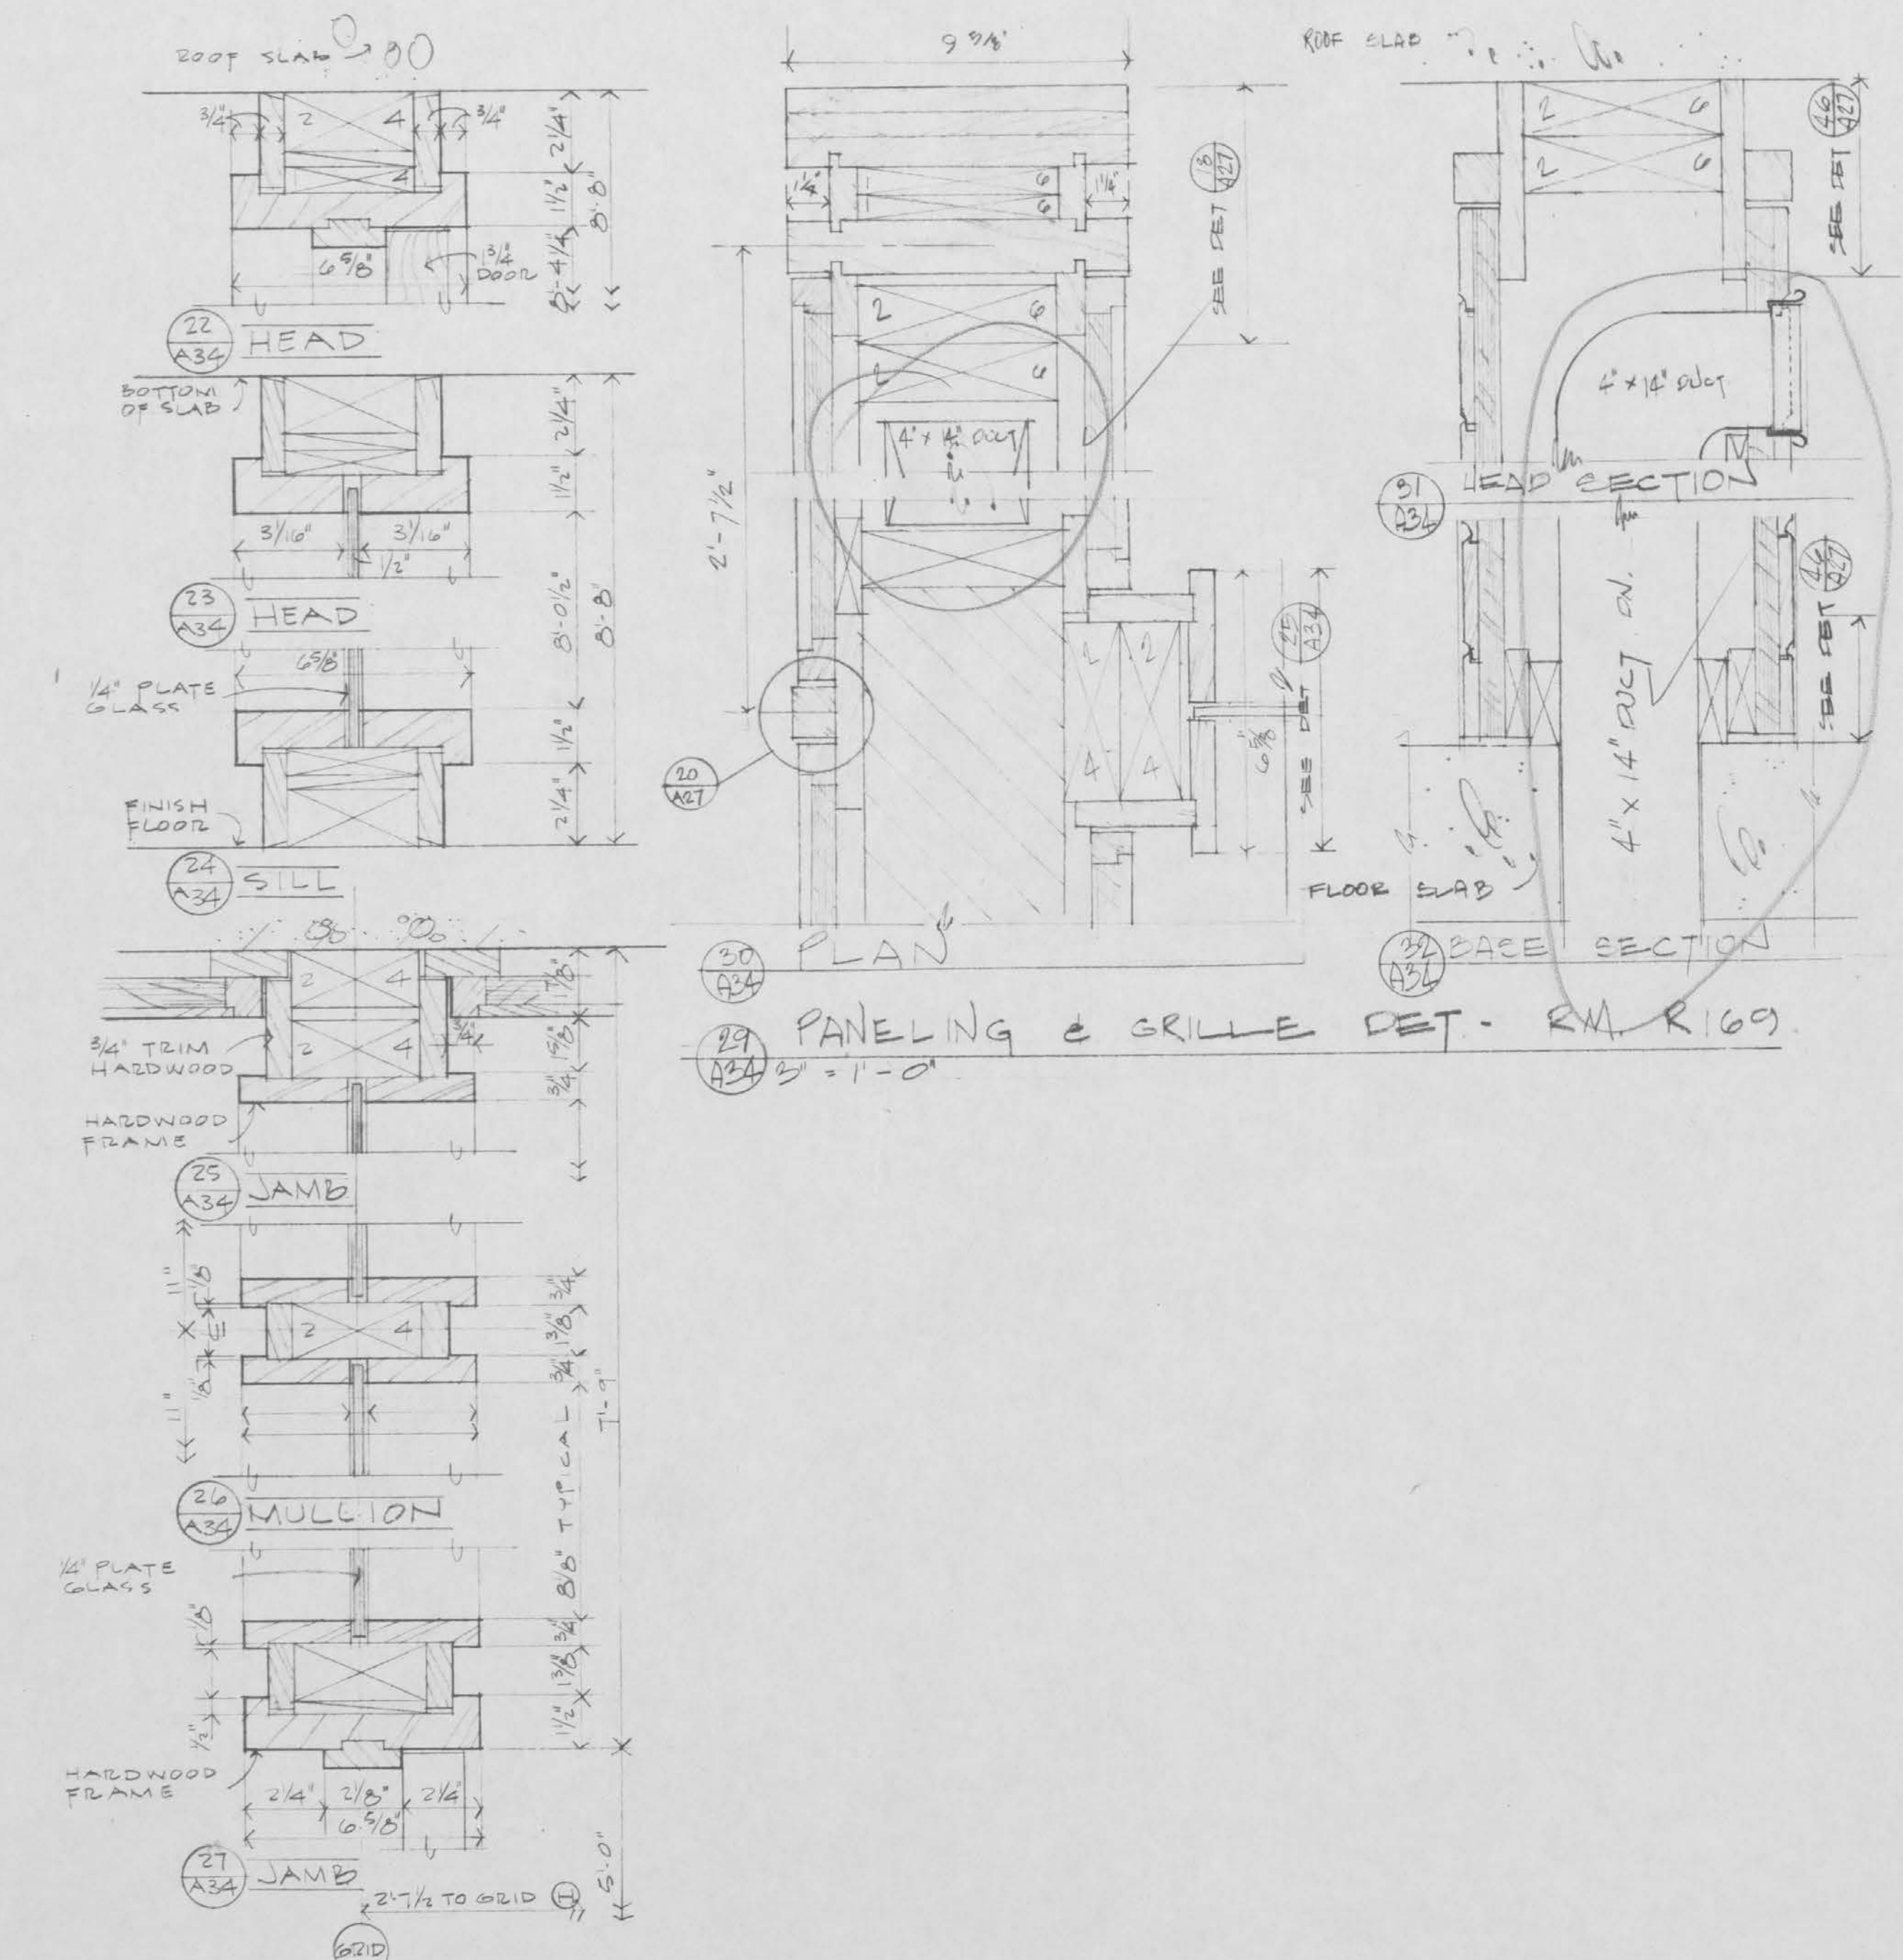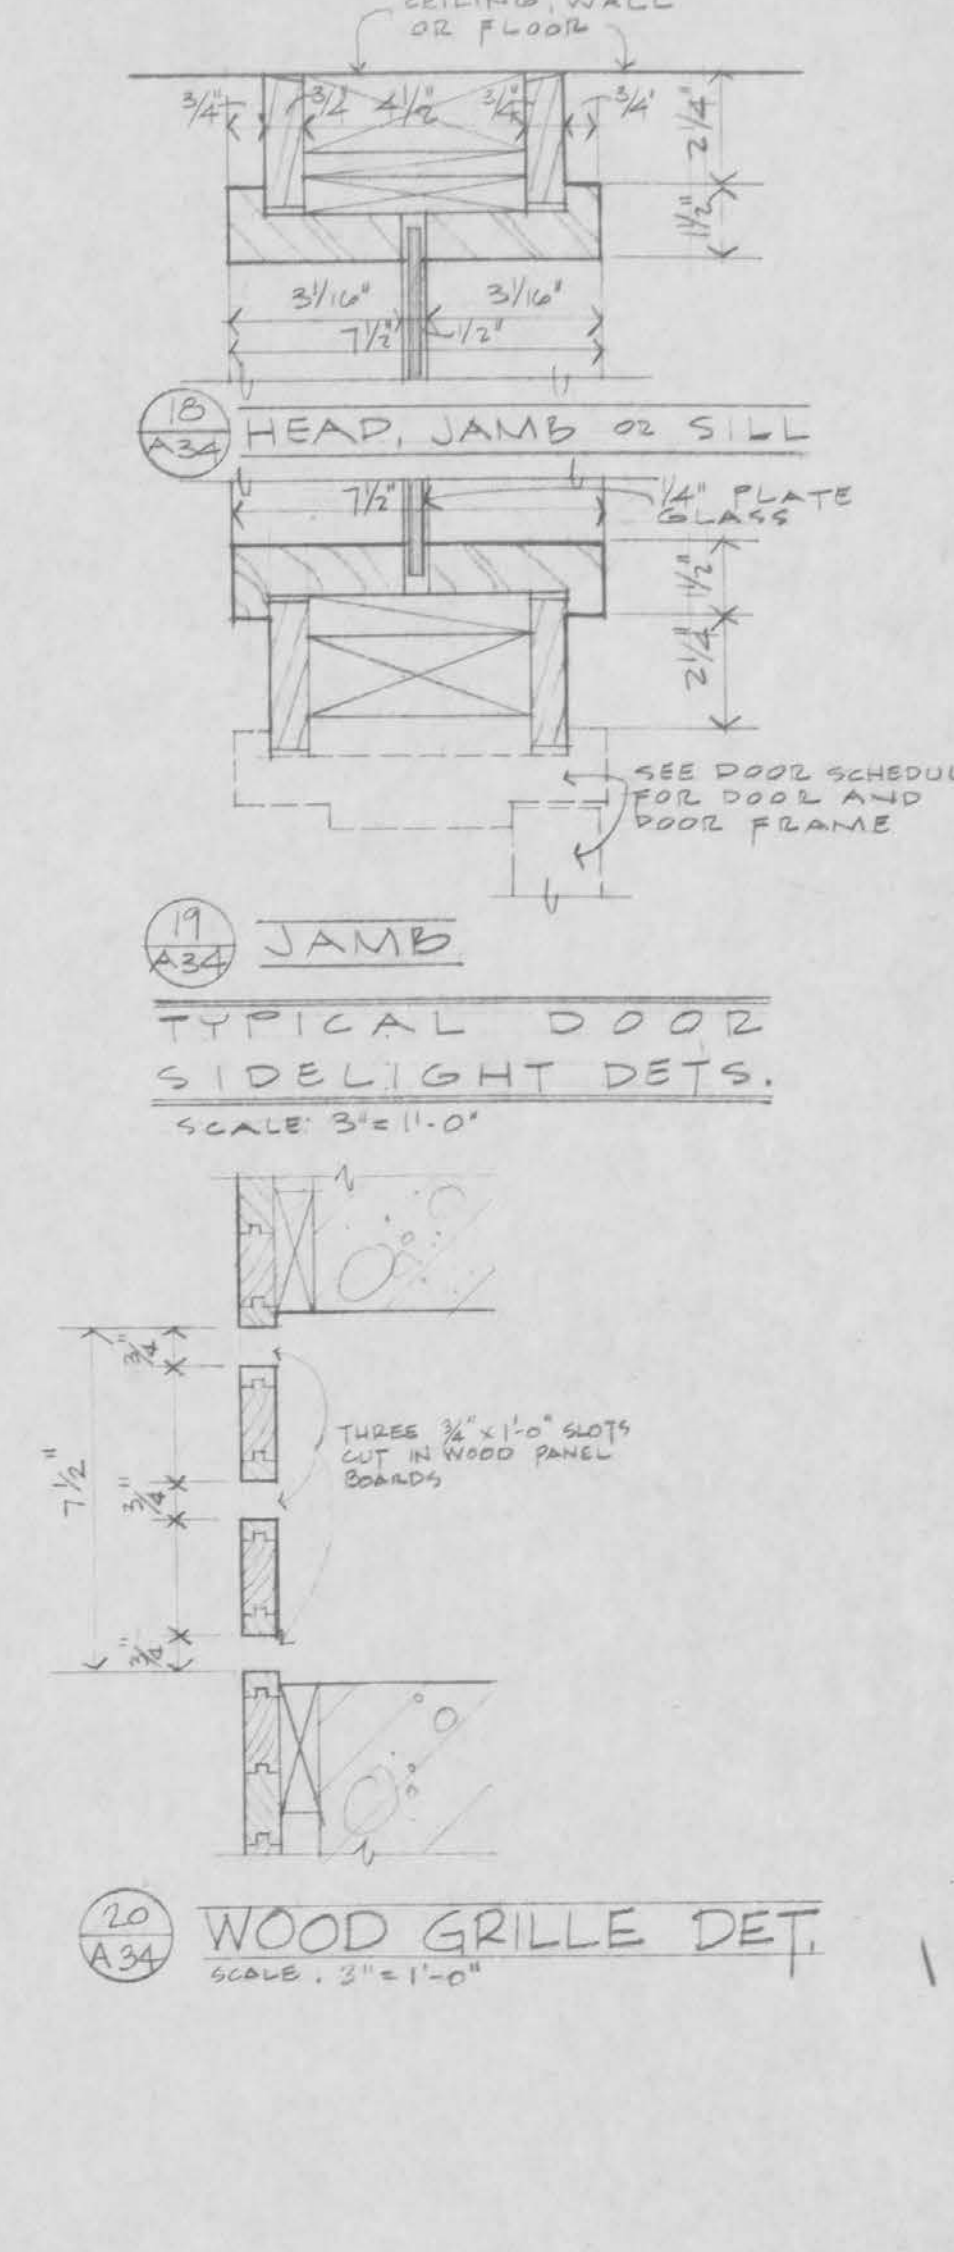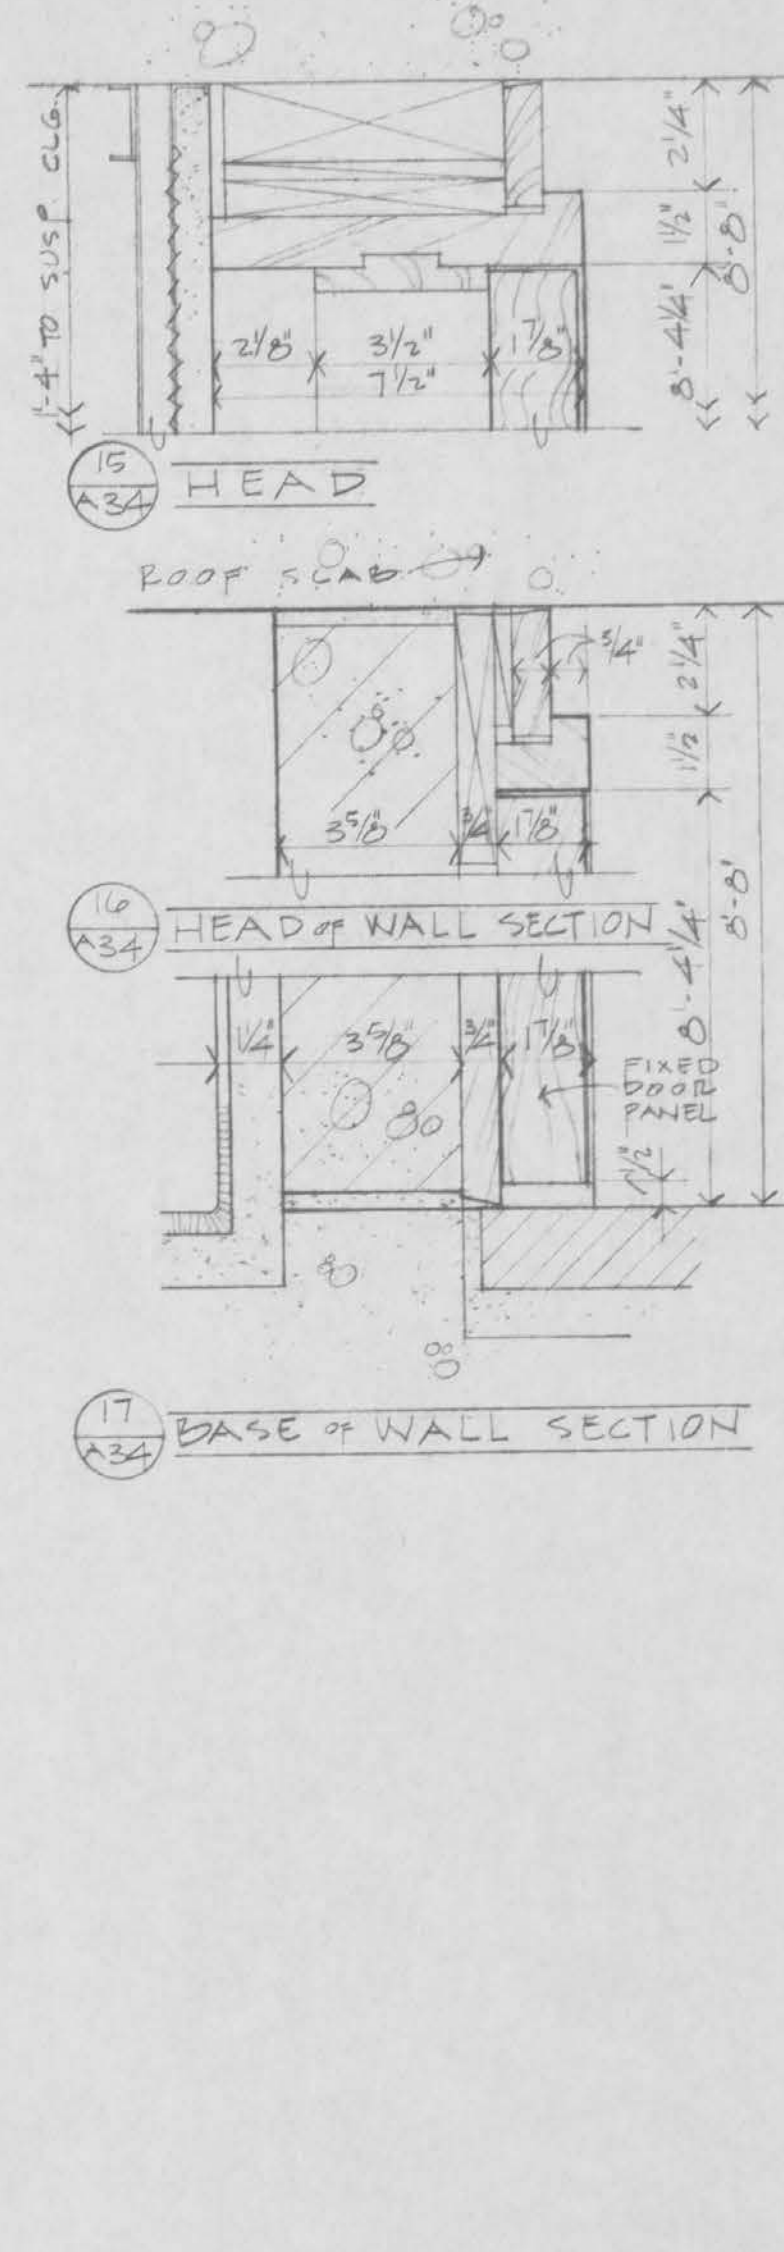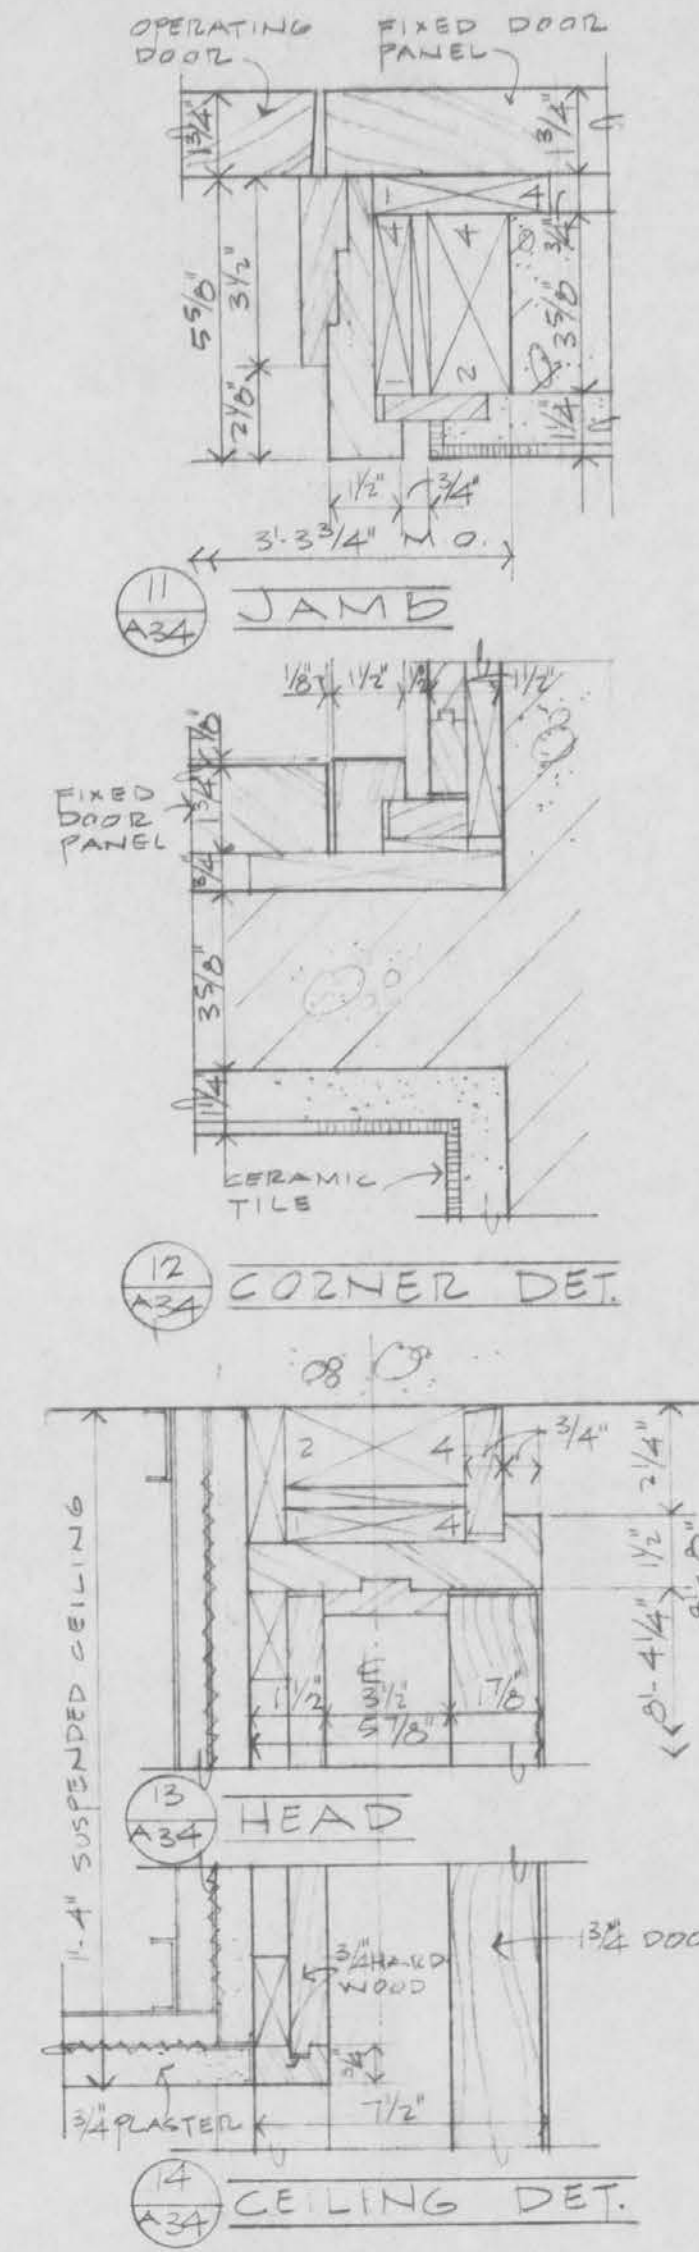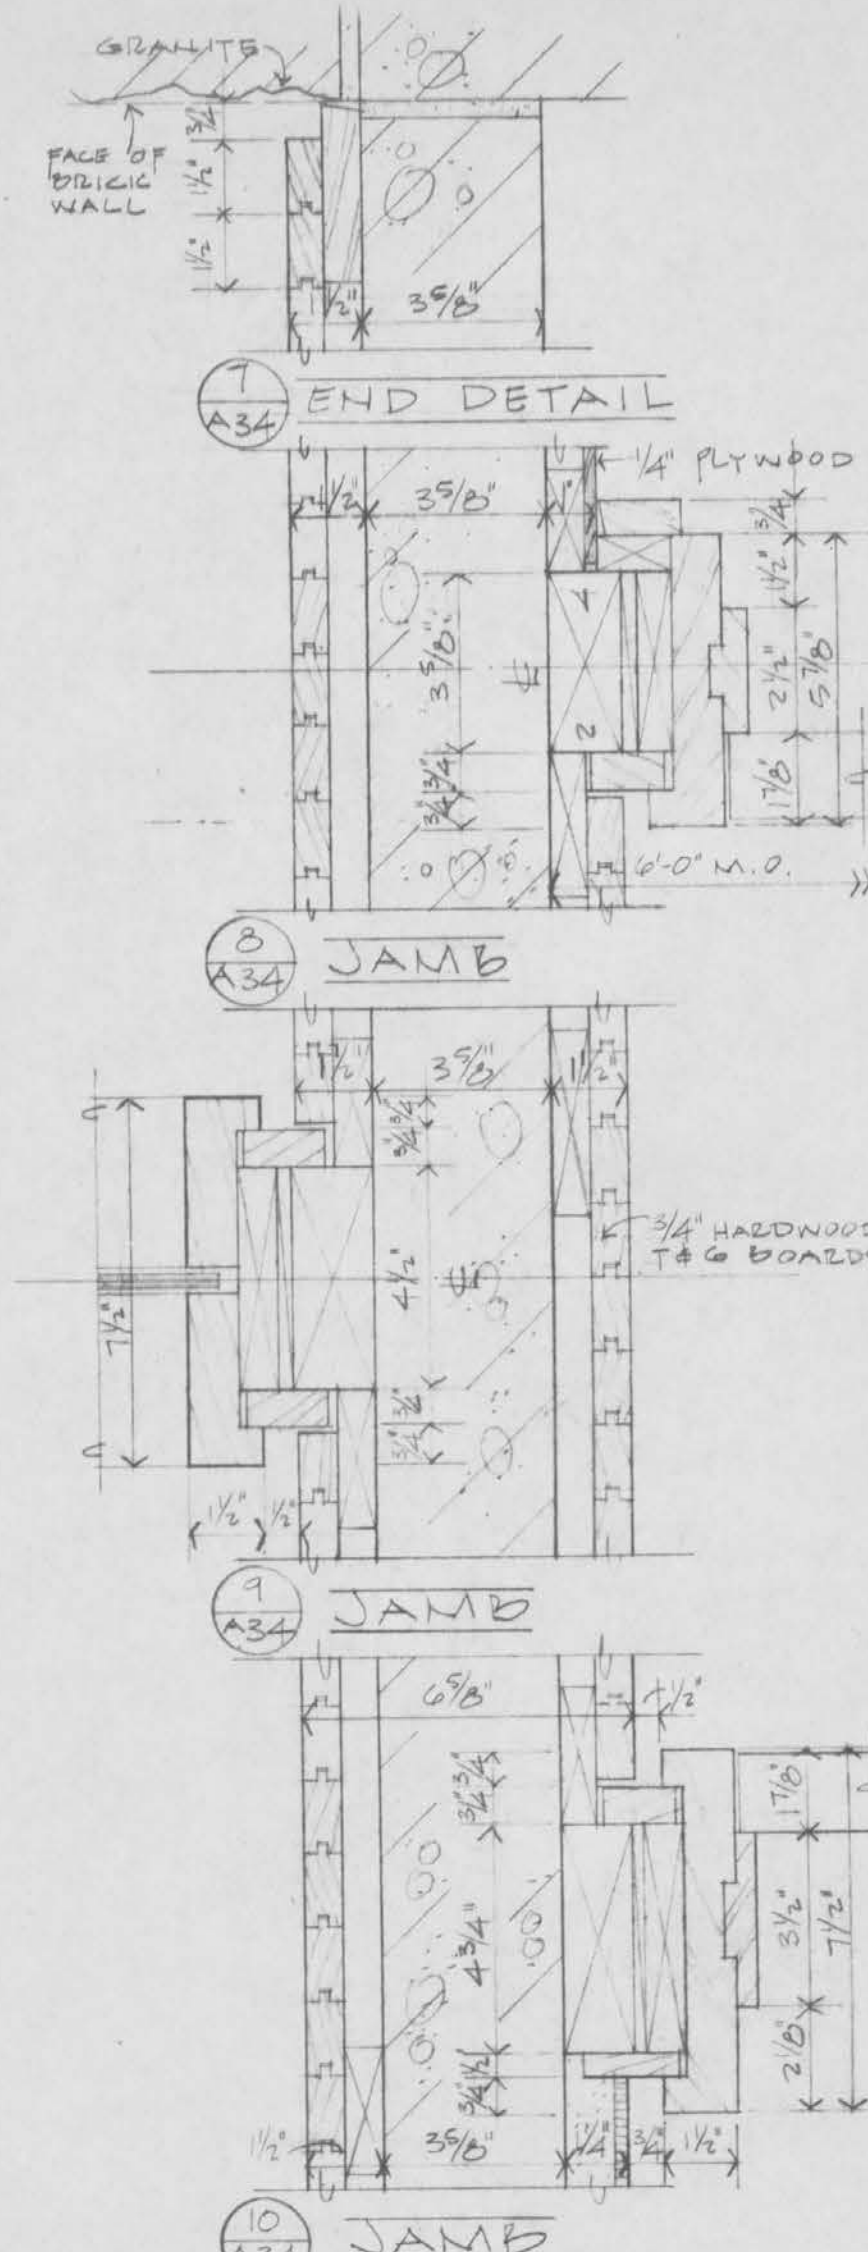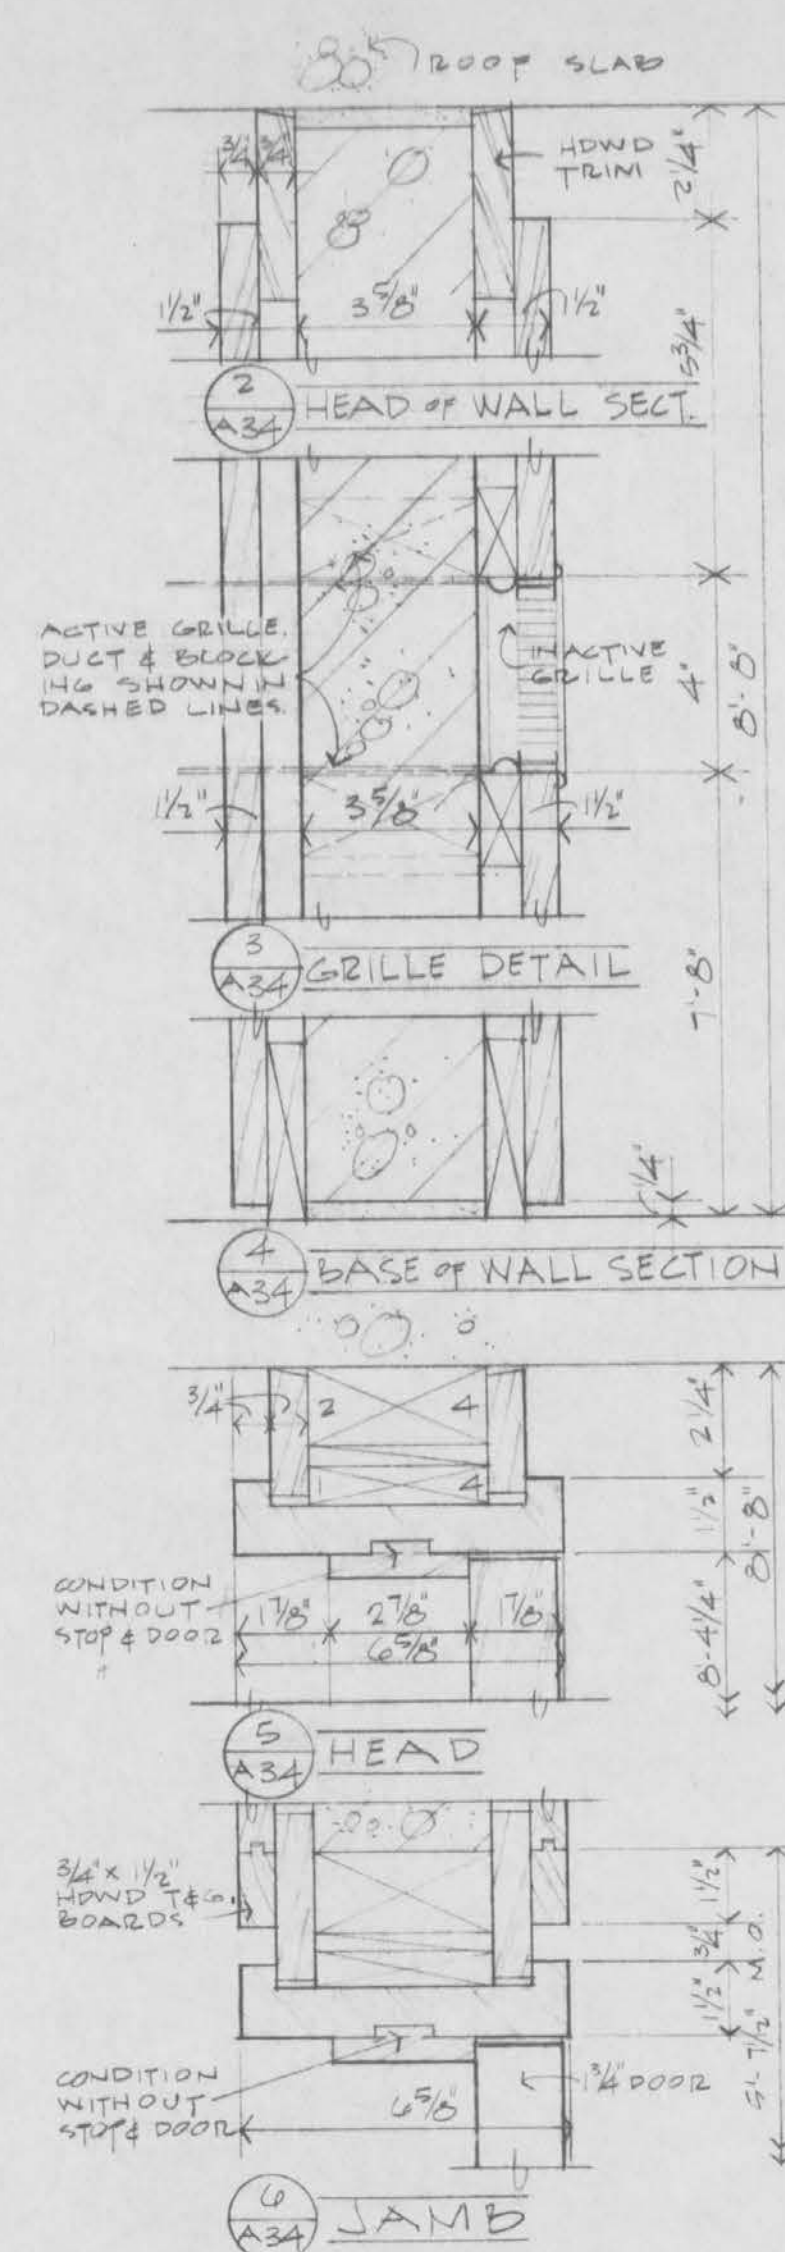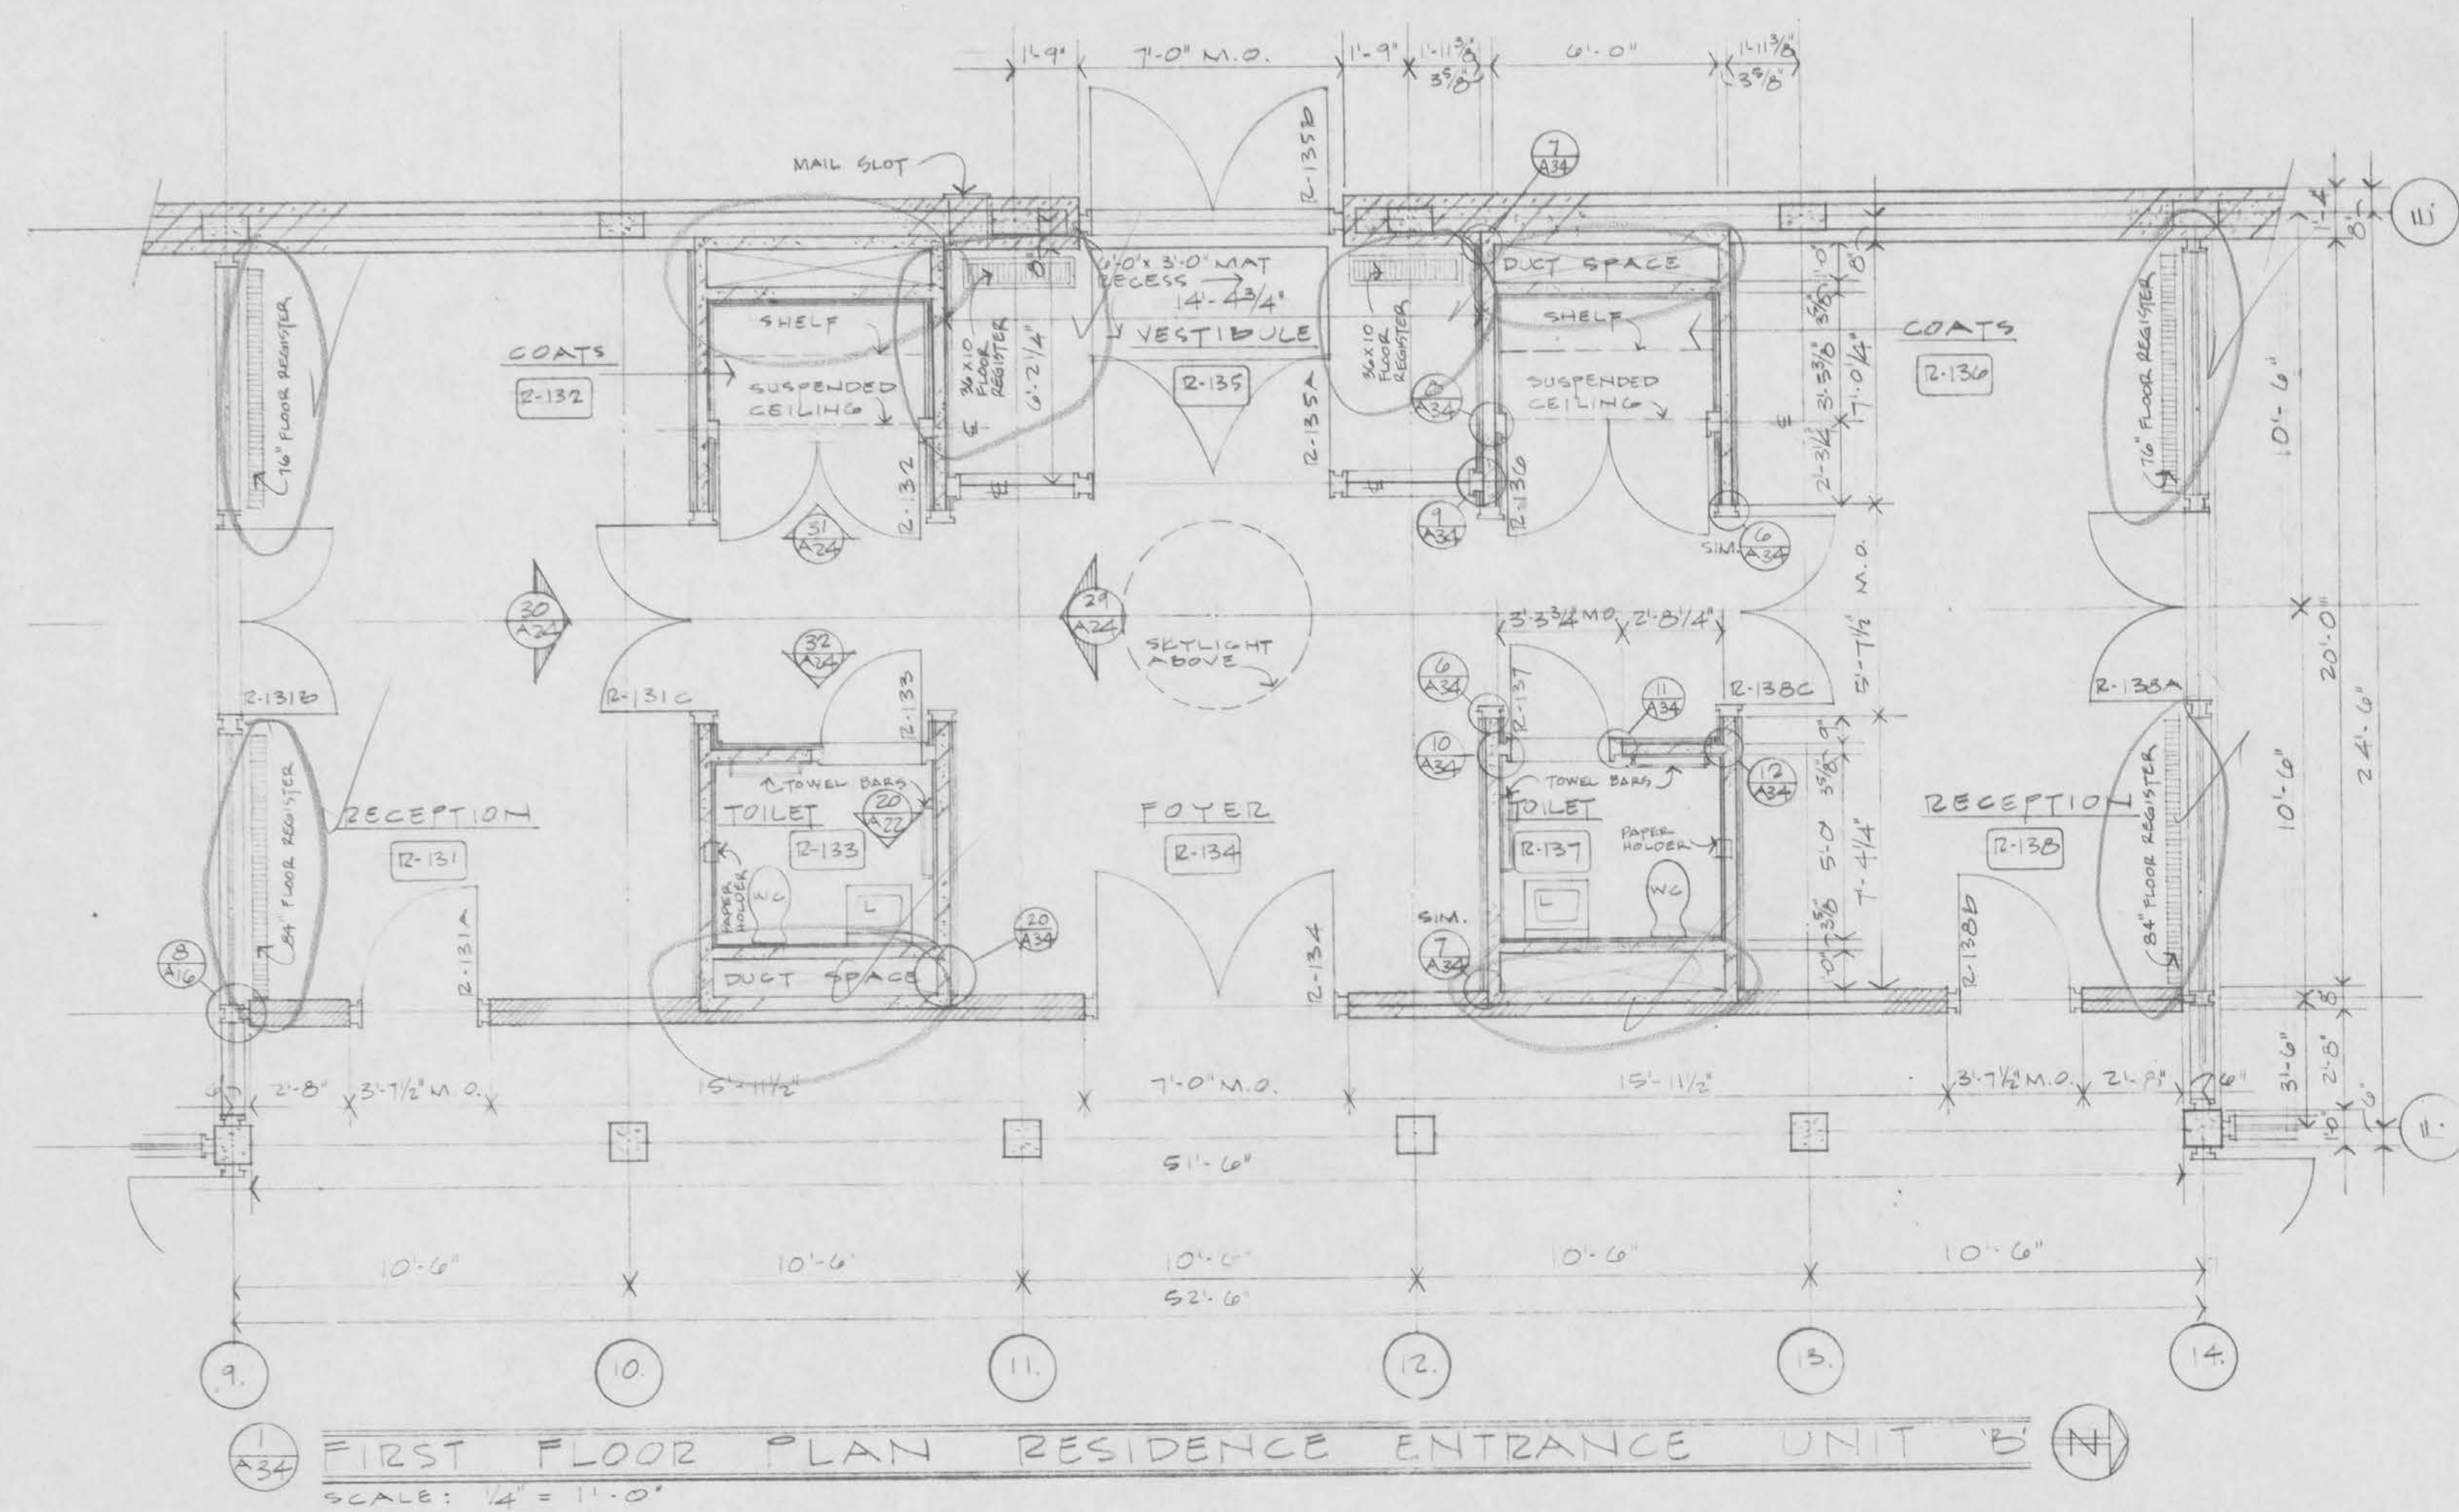

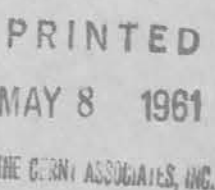

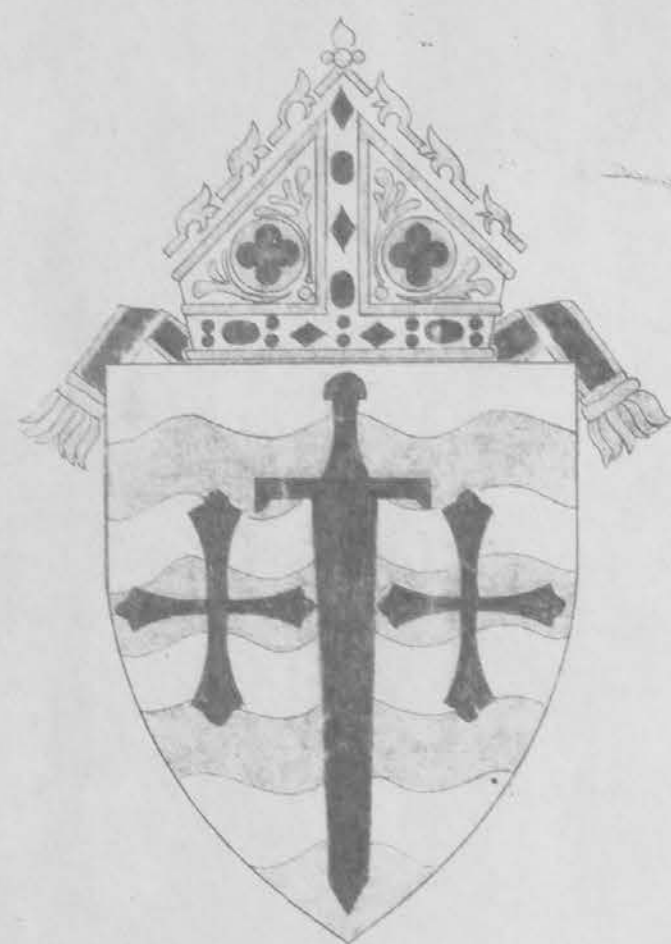

# CHANCERY AND RESIDENCE BUILDINGS FOR THE ARCHDIOCESE OF SAINT PAUL

SAINT PAUL, MINNESOTA

## ARCHITECTURAL

- A1 TITLE SHEET
- A2 PLOT PLAN AND DETAILS
- A3 BASEMENT PLAN
- A4 FIRST FLOOR PLAN
- A5 SECOND FLOOR PLAN - ROOF PLAN
- A6 ROOM FINISH SCHEDULE
- A7 REFLECTED CEILING PLANS
- A8 EXTERIOR ELEVATIONS
- A9 EXTERIOR ELEVATIONS
- A10 BUILDING SECTIONS
- A11 BUILDING SECTIONS
- A12 BUILDING SECTIONS
- A13 BUILDING DETAILS - UNITS "A", "B" & "C"
- A14 BUILDING DETAILS - UNIT "D" & LINK
- A15 WINDOW DETAILS
- A16 WINDOW DETAILS
- A17 EXTERIOR STAIR & STONE DETAILS
- A18 INTERIOR STAIR DETAILS
- A19 INTERIOR STAIR DETAILS
- A20 ELEVATOR, FIREPLACE, CHIMNEY & CHUTE DETAILS
- A21 CHAPEL DETAILS
- A22 TOILET & SERVICE ROOM ELEVATIONS
- A23 INTERIOR ELEVATIONS
- A24 INTERIOR ELEVATIONS
- A25 INTERIOR ELEVATIONS
- A26 CORE PLANS & ELEVATIONS
- A27 MILLWORK & PANELING DETAILS
- A28 MISCELLANEOUS DETAILS
- A29 MILLWORK DETAILS
- A30 MILLWORK DETAILS
- A31 DOOR SCHEDULE
- A32 DOOR & DOOR FRAME DETAILS
- A33 MILLWORK & MISCELLANEOUS DETAILS
- A34 1/4" PLAN - RECEPTION AREA & MILLWORK DETAILS
- A35 1/4" FLOOR PLANS - UNITS "A" & "C"
- A36 1/4" FLOOR PLAN - UNIT "D"
- A37 PORTE COCHERE DETAILS

## STRUCTURAL

- S1 FOUNDATION PLAN
- S2 FIRST FLOOR PLAN
- S3 2ND FLOOR PLAN UNIT "B" ROOF FRAMING PLAN UNITS "A", "B", "C"
- S4 ROOF FRAMING PLAN - UNIT "D"
- S5 FOUNDATION DETAILS - UNITS "A", "B", "C"
- S6 FOUNDATION DETAILS & SCHED. - UNIT "D"
- S7 STRUCTURAL DETAILS - UNIT "D"
- S8 STAIR DETAILS
- S9 COLUMN & FOOTING SCHEDULE UNITS "A", "B", "C"
- S10 JOIST SCHEDULE UNITS "A", "B", "C"
- S11 BEAM SCHEDULE UNITS "A", "B", "C"
- S12 BEAM SCHEDULE UNITS "A", "B", "C"
- S13 BEAM SCHEDULE UNIT "D"

## SITE WORK

- CE1 EXISTING SITE PLAN
- CE2 PROPOSED SITE PLAN
- CE3 CRIB WALL DETAILS & ALTERNATE GRADING
- CE4 SITE CROSS SECTIONS

## ABBREVIATIONS

|                            |                              |                        |                                  |
|----------------------------|------------------------------|------------------------|----------------------------------|
| A.P. ACCESS PANEL          | ELECT. ELECTRICAL            | K.C. KEENE'S CEMENT    | SQ. FT. SQUARE FOOT (FEET)       |
| A.C. AIR CONDITIONING      | ELEV. ELEVATION              | LAV. LAVATORY          | STRUCT. STRUCTURAL               |
| ALT. ALTERNATE             | EQ. EQUAL                    | LWT. LIGHTWEIGHT       | S. SWITCH                        |
| ALUM. ALUM. NUM.           | EXH. EXHAUST                 | M.O. MASONRY OPENING   | SIM. SIMILAR                     |
| ASPH. ASPHALT              | EXIST. EXISTING              | MECH. MECHANICAL       | T.C.V. TEMPERATURE CONTROL VALVE |
| @ AT                       | EXP. EXPANSION               | MIN. MINIMUM           | TYP. TYPICAL                     |
| B.W.V. BACK WATER VALVE    | FIN. FINISH (ED)             | MISC. MISCELLANEOUS    | U.H. UNIT HEATER                 |
| BSMT. BASEMENT             | FE. FIRE EXTINGUISHER        | N.I.C. NOT IN CONTRACT | VENT. VENTILATING                |
| DM. BENCH MARK             | F. FIRE LINE                 | N.T.S. NOT TO SCALE    | V.C.P. VITRIFIED CLAY TILE PIPE  |
| BLK. BLOCK                 | FLR. FLOOR                   | NOM. NOMINAL           | W. WASTE                         |
| BOT. BOTTOM                | FDS. FLOOR DIVIDER STRIP     | NQ. NUMBER             | W.C. WATER CLOSET                |
| BLDG. BUILDING             | FD. FLOOR DRAIN              | OC. ON CENTER          | W.F. WIDE-FLANGE BEAM            |
|                            | FTG. FOOTING                 | OD. OUTSIDE DIAMETER   | WDW. WINDOW                      |
|                            | FA. FRESH AIR                | PLAS. PLASTER          | W/ WITH                          |
| G.I. CAST IRON             | G.I. GALVANIZED IRON         | R. PLATE               |                                  |
| CLG. CEILING               | G.S. G.S. GENERAL CONTRACTOR | PLYWD. PLYWOOD         |                                  |
| C. CENTER LINE             | GL. GLASS                    | REINF. REINFORCING     |                                  |
| CHW. CIRCULATING HOT WATER | GLA. GLAZED                  | R.A. RETURN AIR        |                                  |
| CLOCK                      | GR. GRILLE                   | R. RISERS              |                                  |
| C.W. COLD WATER            |                              | RF. ROOF               |                                  |
| COL. COLUMN                |                              | R. ROUND               |                                  |
| COMP. COMPOSITION          |                              | SCHED. SCHEDULE        |                                  |
| CONC. CONCRETE             |                              | S.M. SECTION MODULUS   |                                  |
| COND. CONDITION            |                              | SHT. SHEET             |                                  |
| CONST. CONSTRUCTION        |                              | SH. SHOWER             |                                  |
| CONT. CONTINUOUS           |                              | SPEC. SPECIFICATIONS   |                                  |
| CONV. CONNECTOR            |                              | S. SQUARE              |                                  |
| CR. COURSE                 |                              |                        |                                  |
| DRWR. DRAWER               |                              |                        |                                  |
| DPR. DAMPER                |                              |                        |                                  |
| DET. DETAIL                |                              |                        |                                  |
| DD. DITTO                  |                              |                        |                                  |
| D.S. DOWNSPOUT             |                              |                        |                                  |
| DR. DRAIN                  |                              |                        |                                  |
| D.F. DRINKING FOUNTAIN     |                              |                        |                                  |
| JT. JOINT                  |                              |                        |                                  |


## MECHANICAL

- M1 UNDERFLOOR PLUMBING
- M2 BASEMENT HEATING & PLUMBING
- M3 BASEMENT VENT & A.C.
- M4 1ST & 2ND FLOORS UNIT "B" VENT. & A.C. DETAILS
- M5 1ST & 2ND FLOORS PLUMB., VENT., & A.C.
- M6 RADIANT PANEL HEATING SYSTEMS
- M7 ROOF PLAN
- M8 PLUMBING RISERS & DETAILS
- M9 VENTILATING & AIR CONDITIONING DET.
- M10 HEATING DETAILS

## ELECTRICAL

- E1 BASEMENT FLOOR UNITS "A", "B", "C" & "D"
- E2 FIRST FLOOR UNITS "A", "B", "C" & "D"
- E3 SECOND FL. UNIT "B" - FIRST FLR. CHAPEL
- E4 DIAGRAMS

## KEY PLAN

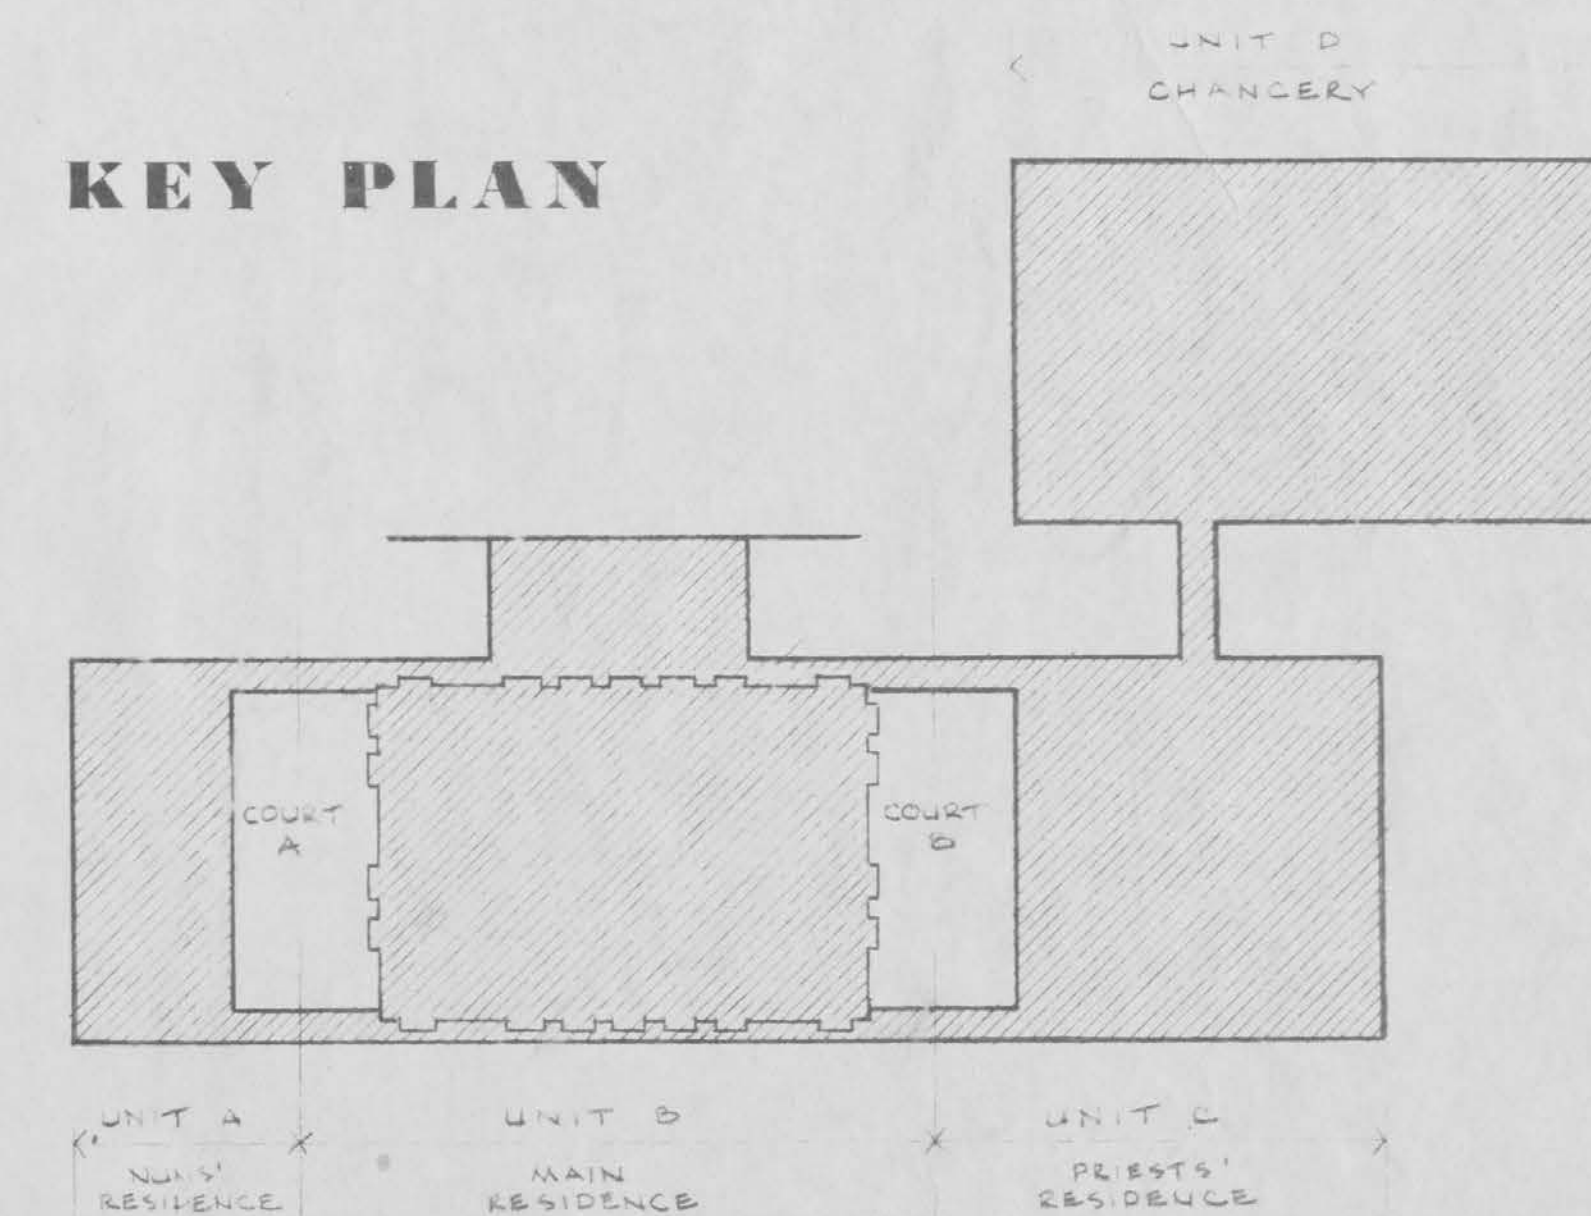

## SYMBOLS

|                  |                            |
|------------------|----------------------------|
| EARTH            | WOOD (STRUCTURAL)          |
| SAND/GRAVEL      | WOOD (FINISH)              |
| CONCRETE         | BRICK                      |
| CONCRETE BLOCK   | 6" BLK. WALL (2 1/2" BLK.) |
| STONE            | W/ SOLID PARGING BETWEEN   |
| HOLLOW CLAY TILE | (A) WINDOW TYPE            |
| RIGID INSULATION | (102) ROOM NUMBER          |
| BATT INSULATION  | (S) DET. NO. DETAIL NUMBER |
| PLASTER          | (E) ELEVATION NUMBER       |
| METAL            | (2) GRID LINE              |
|                  | (B) SECTION                |
|                  | (D) REVISION               |

PRINTED  
MAY 8 1961

DATE  
FEB 15, 1961  
DRAWN  
P. SHATTUCK  
CHECKED

I HEREBY CERTIFY THAT THIS PLAN, SPECIFICATION, OR REPORT WAS PREPARED BY ME OR UNDER MY DIRECT SUPERVISION AND THAT I AM A DULY REGISTERED ARCHITECT OR ENGINEER UNDER THE LAWS OF THE STATE OF MINNESOTA.  
DATE FEB 15, 1961  
REG. No. 1104  
REG. No.


THE GERRY ASSOCIATES, INC.  
architects - engineers - planners  
minneapolis - saint paul, minnesota

CHANCERY AND RESIDENCE BUILDINGS  
FOR THE ARCHDIOCESE OF SAINT PAUL  
Saint Paul Minnesota

TITLE SHEET

SCALE NONE

SHEET NUMBER  
A1  
PROJECT NUMBER  
57-90

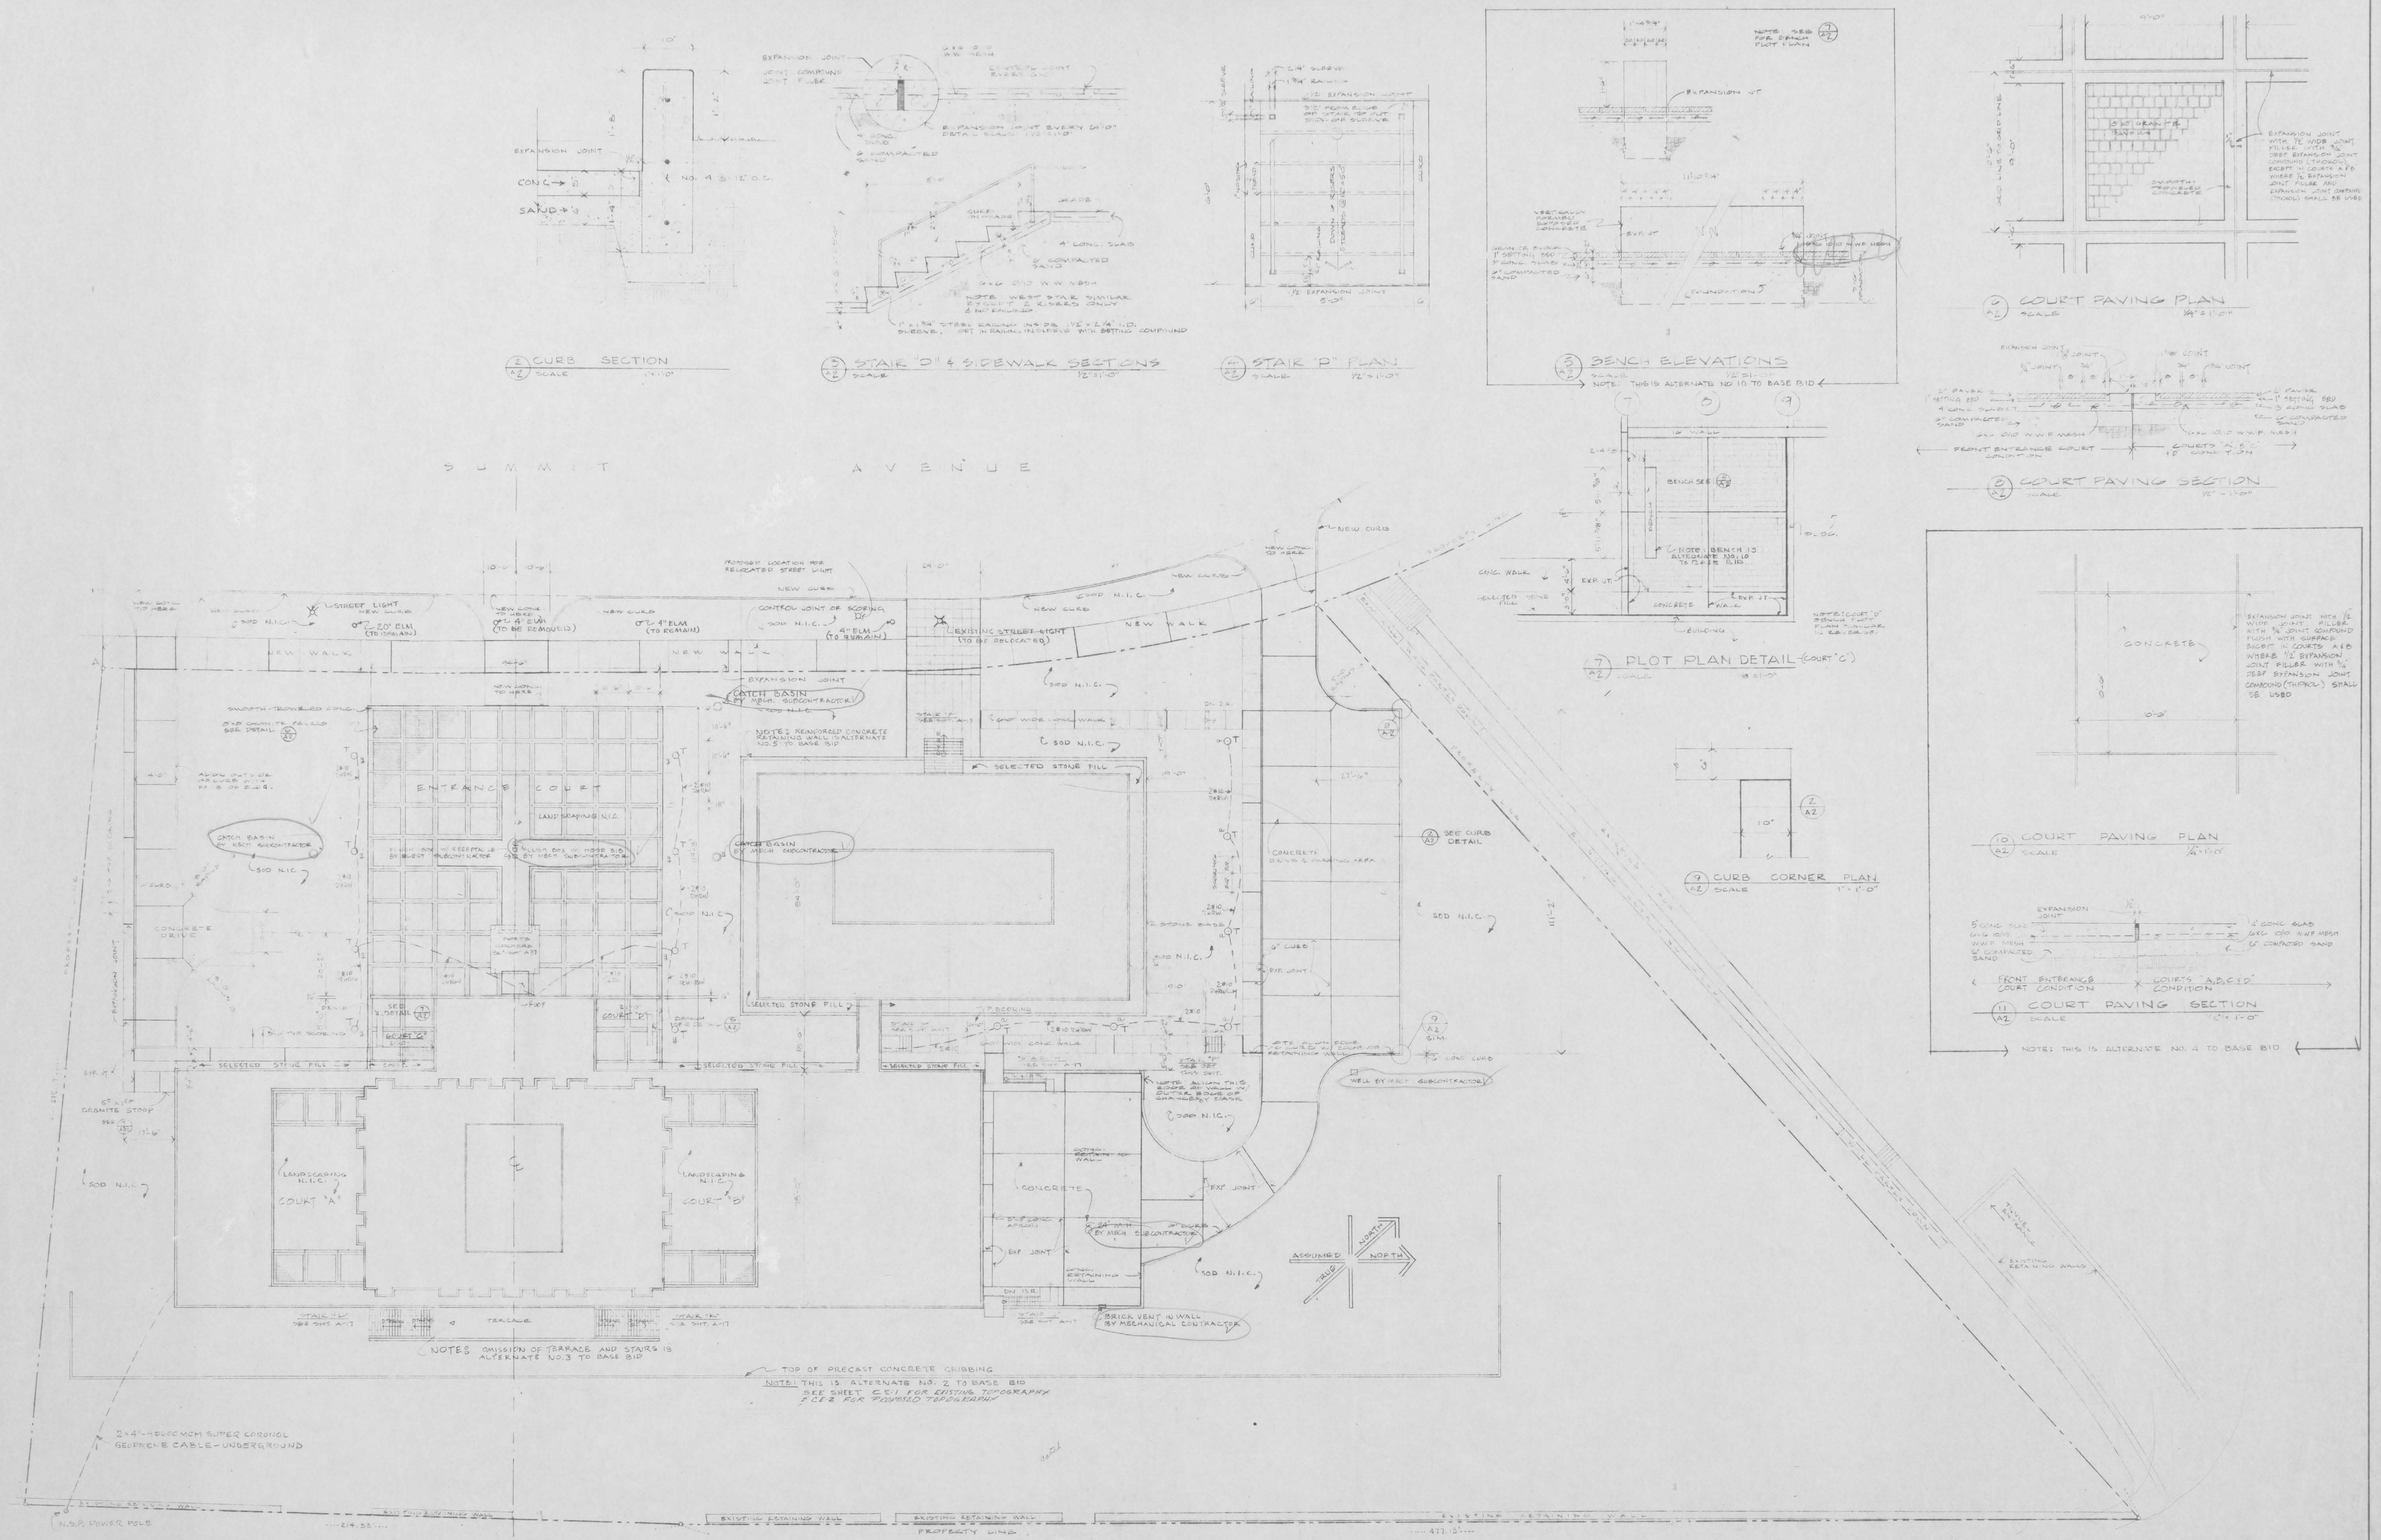

PRINTED  
MAY 8 1981  
THE CERNY ASSOCIATES, INC.

DATE  
FEB. 13, 1981  
DRAWN  
D. SHATTUCK  
CHECKED

I HEREBY CERTIFY THAT THIS PLAN, SPECIFICATION, OR REPORT  
WAS PREPARED BY ME OR UNDER MY DIRECT SUPERVISION  
AND THAT I AM A duly REGISTERED ARCHITECT OR ENGINEER  
UNDER THE LAWS OF THE STATE OF MINNESOTA.  
DATE FEB. 15, 1981  
REG. No. 1764  
REG. No.

THE CERNY ASSOCIATES, INC.  
architects / engineers / planners  
minneapolis • saint paul, minnesota

CHANCERY AND RESIDENCE BUILDINGS  
FOR THE ARCHDIOCESE OF SAINT PAUL  
Saint Paul  
Minnesota

PLOT PLAN  
AND DETAILS  
SCALE: 1/8" = 1'-0"

SHEET NUMBER  
A 2  
PROJECT NUMBER  
57-90