




St. Paul-Ramsey Medical Center.
Hospital and Medical Center Records.

Copyright Notice:

This material may be protected by copyright law (U.S. Code, Title 17). Researchers are liable for any infringement. For more information, visit www.mnhs.org/copyright.

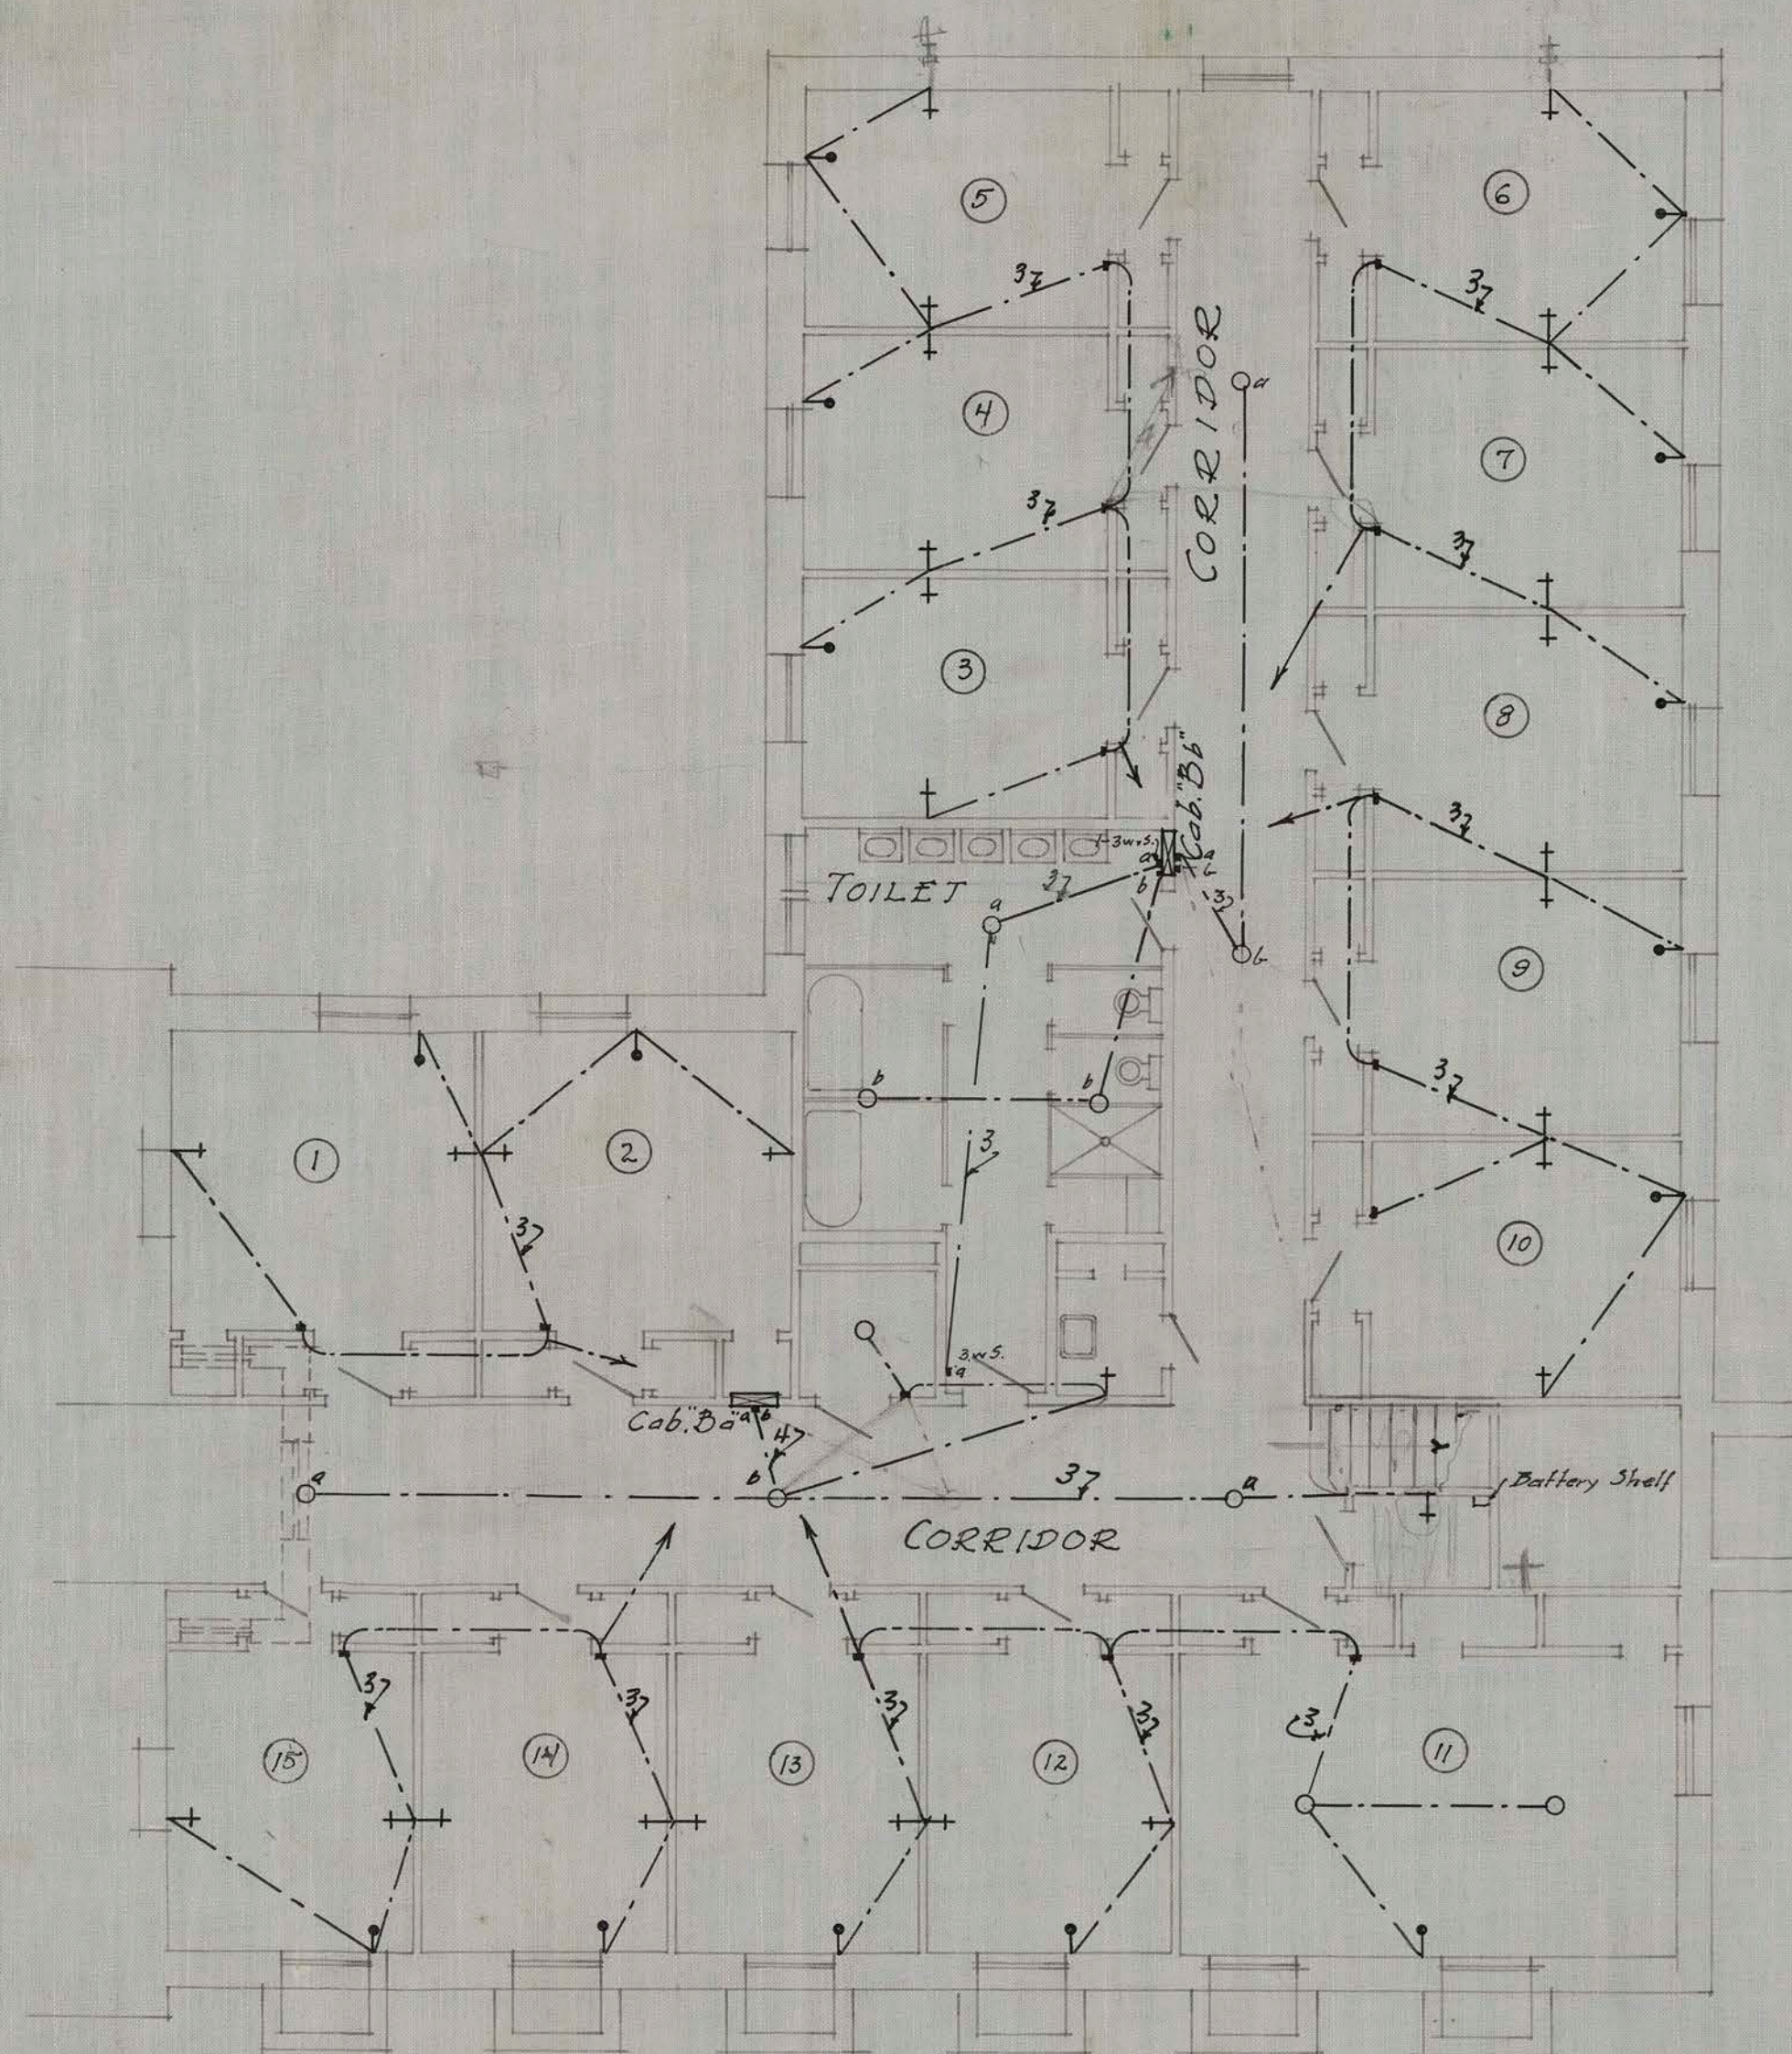

ELECTRICAL SYMBOLS

- Conduit
- Floor Plug
- ⊥ Bracket Outlet
- Ceiling Outlet
- Switch

BASEMENT FLOOR PLAN
ELECTRICAL

MECHANICAL EQUIPMENT
ADDITION TO NURSES HOME
CITY & COUNTY HOSPITAL
ST. PAUL, MINNESOTA.
G. H. JOHNSTON - ARCHITECT

ST. PAUL, MINNESOTA.
MADE BY G.H.P. TRACED BY C.I.G. CHECKED BY C.T.J.
SCALE 1/4" = 1'-0" DATE May 12, 1916
SET NO. ORDER NO. 2212 SHEET NO. 1