




St. Paul-Ramsey Medical Center.
Hospital and Medical Center Records.

Copyright Notice:

This material may be protected by copyright law (U.S. Code, Title 17). Researchers are liable for any infringement. For more information, visit www.mnhs.org/copyright.

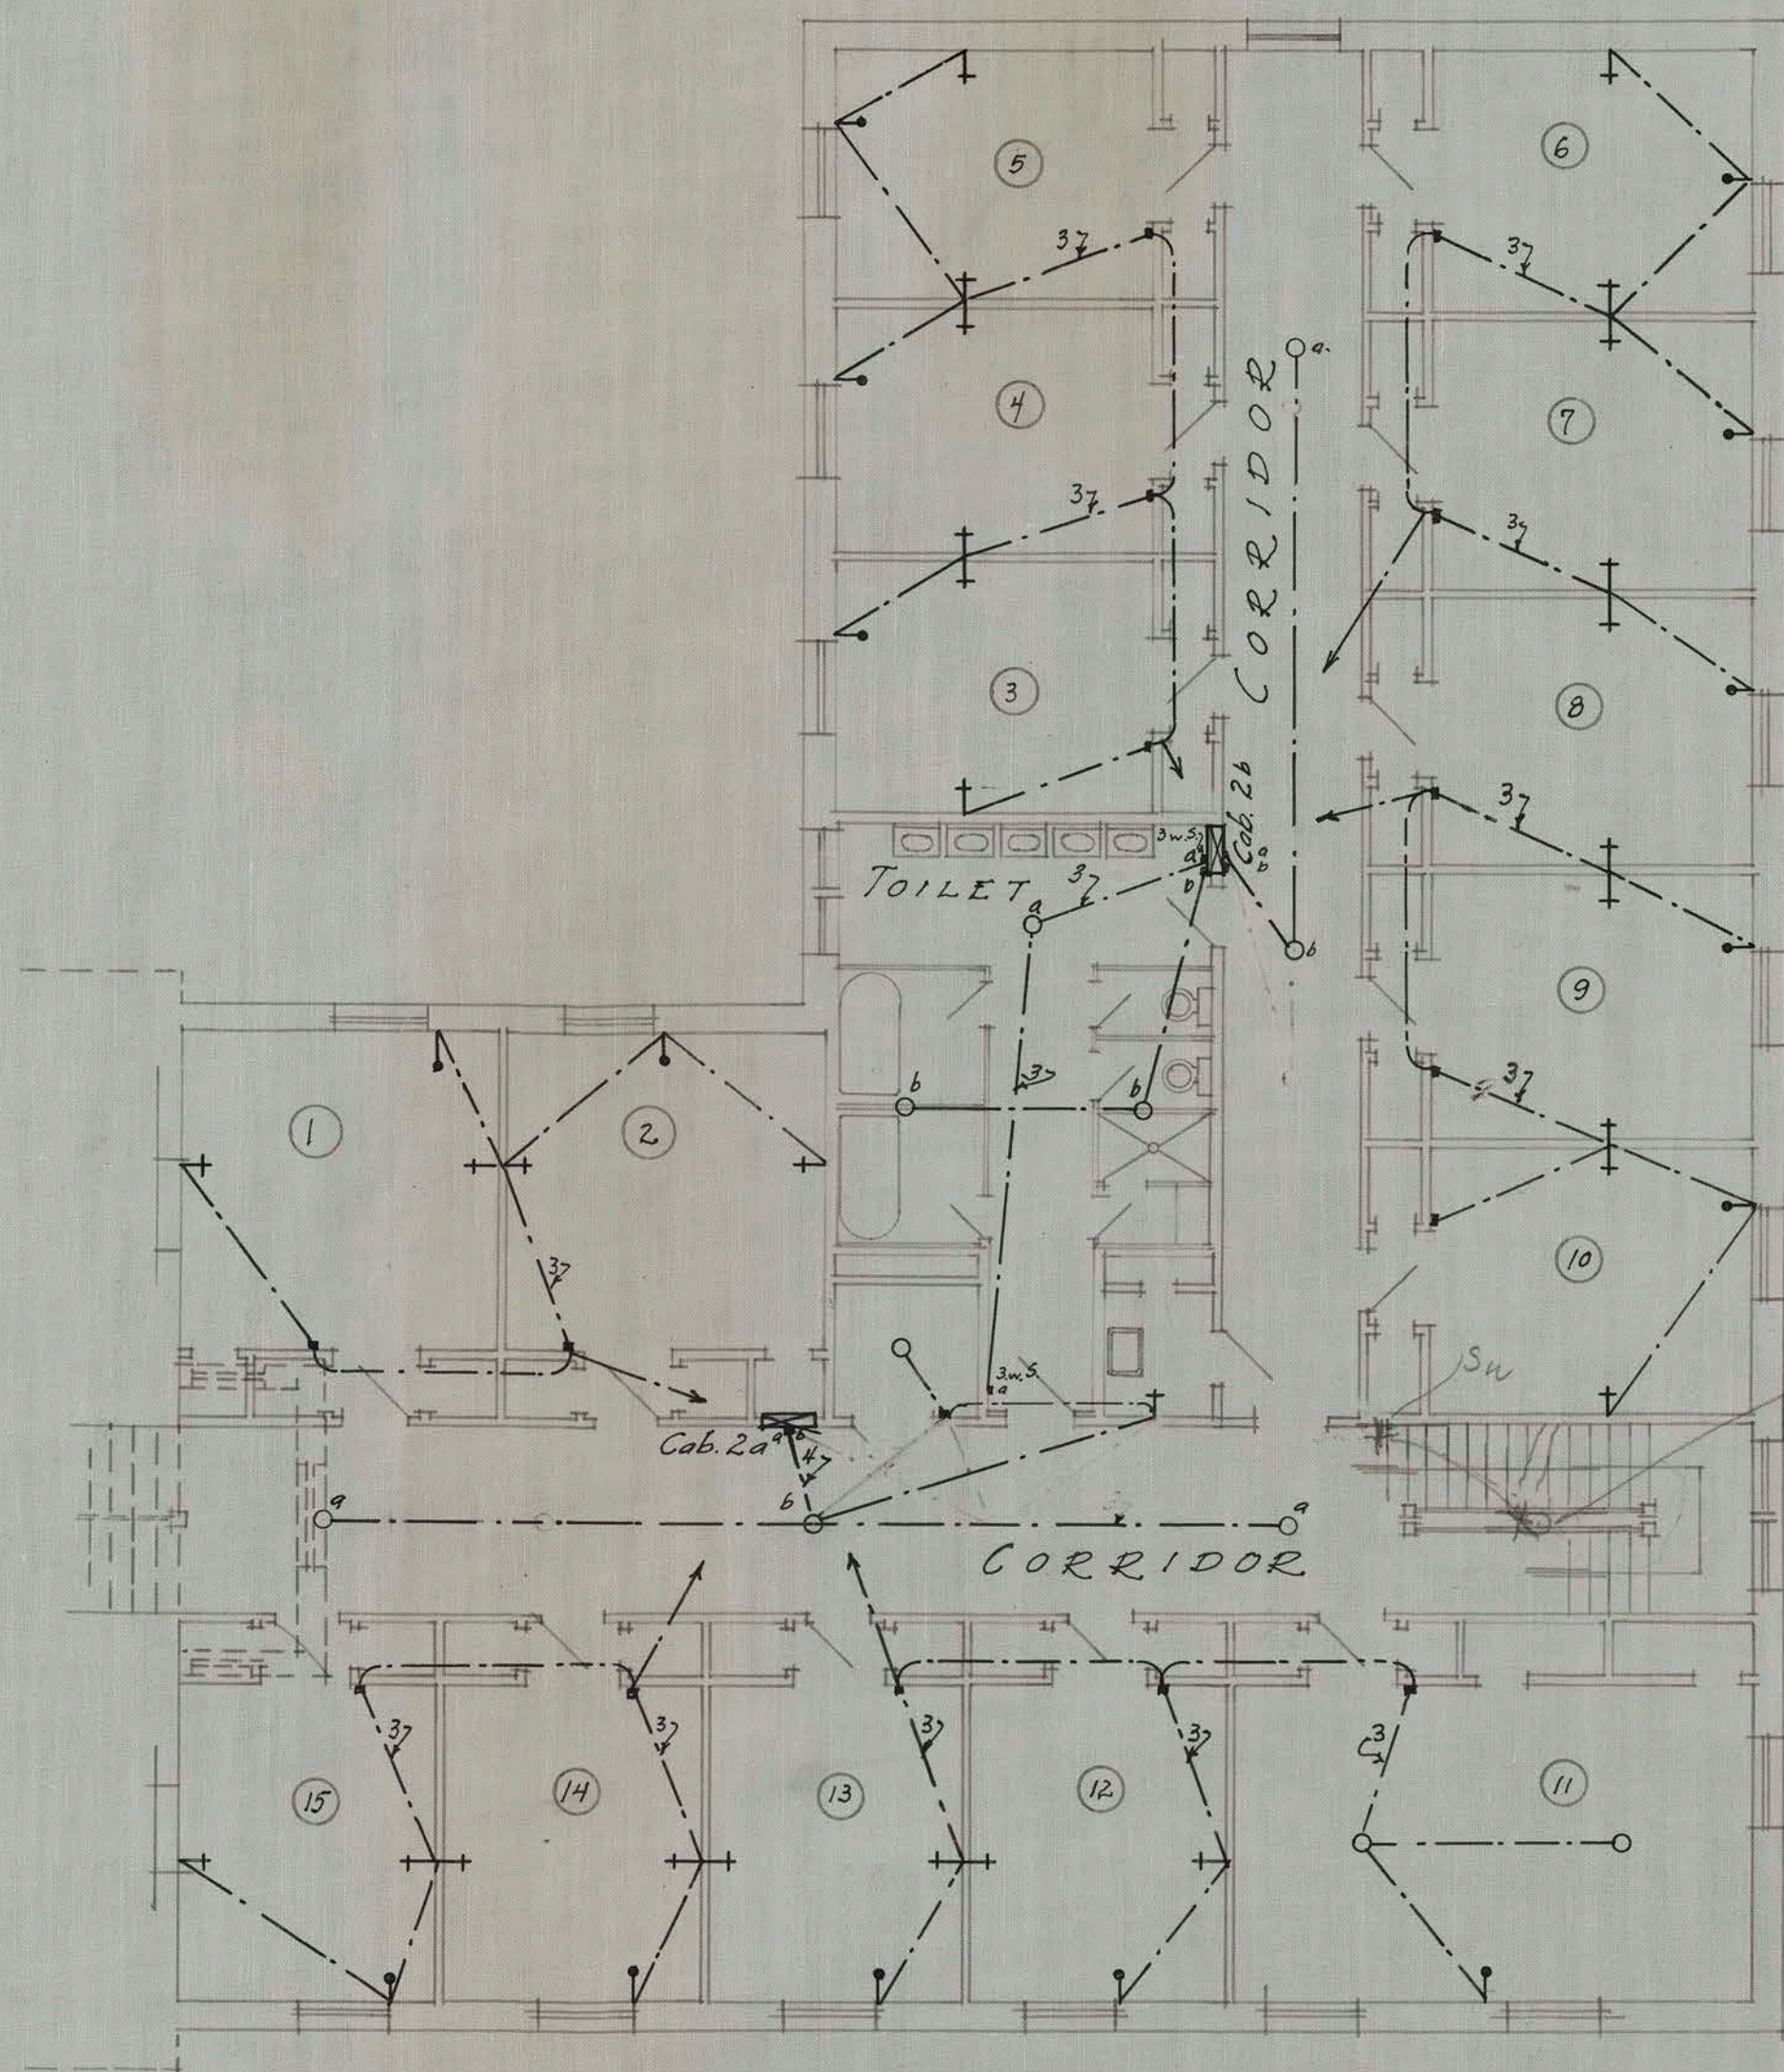

SECOND FLOOR PLAN
ELECTRICAL

MECHANICAL EQUIPMENT
ADDITION TO NURSES HOME
CITY & COUNTY HOSPITAL
ST. PAUL, MINNESOTA.
C. H. JOHNSTON - ARCHITECT
ST. PAUL, MINNESOTA.
MADE BY G.H.P. TRACED BY C.E.G. CHECKED BY G.T.J.
SCALE $\frac{1}{8}" = 1'-0"$ DATE May 12, 1916
SET NO. ORDER NO. 2212 SHEET NO. 3