




VIRTUACTIVE

PRELIMINARY PLANS,
NOT FOR CONSTRUCTION

HOMESTEAD COMMUNITIES - DUPLEX - TRANSITIONAL

Client Name
ADDRESS

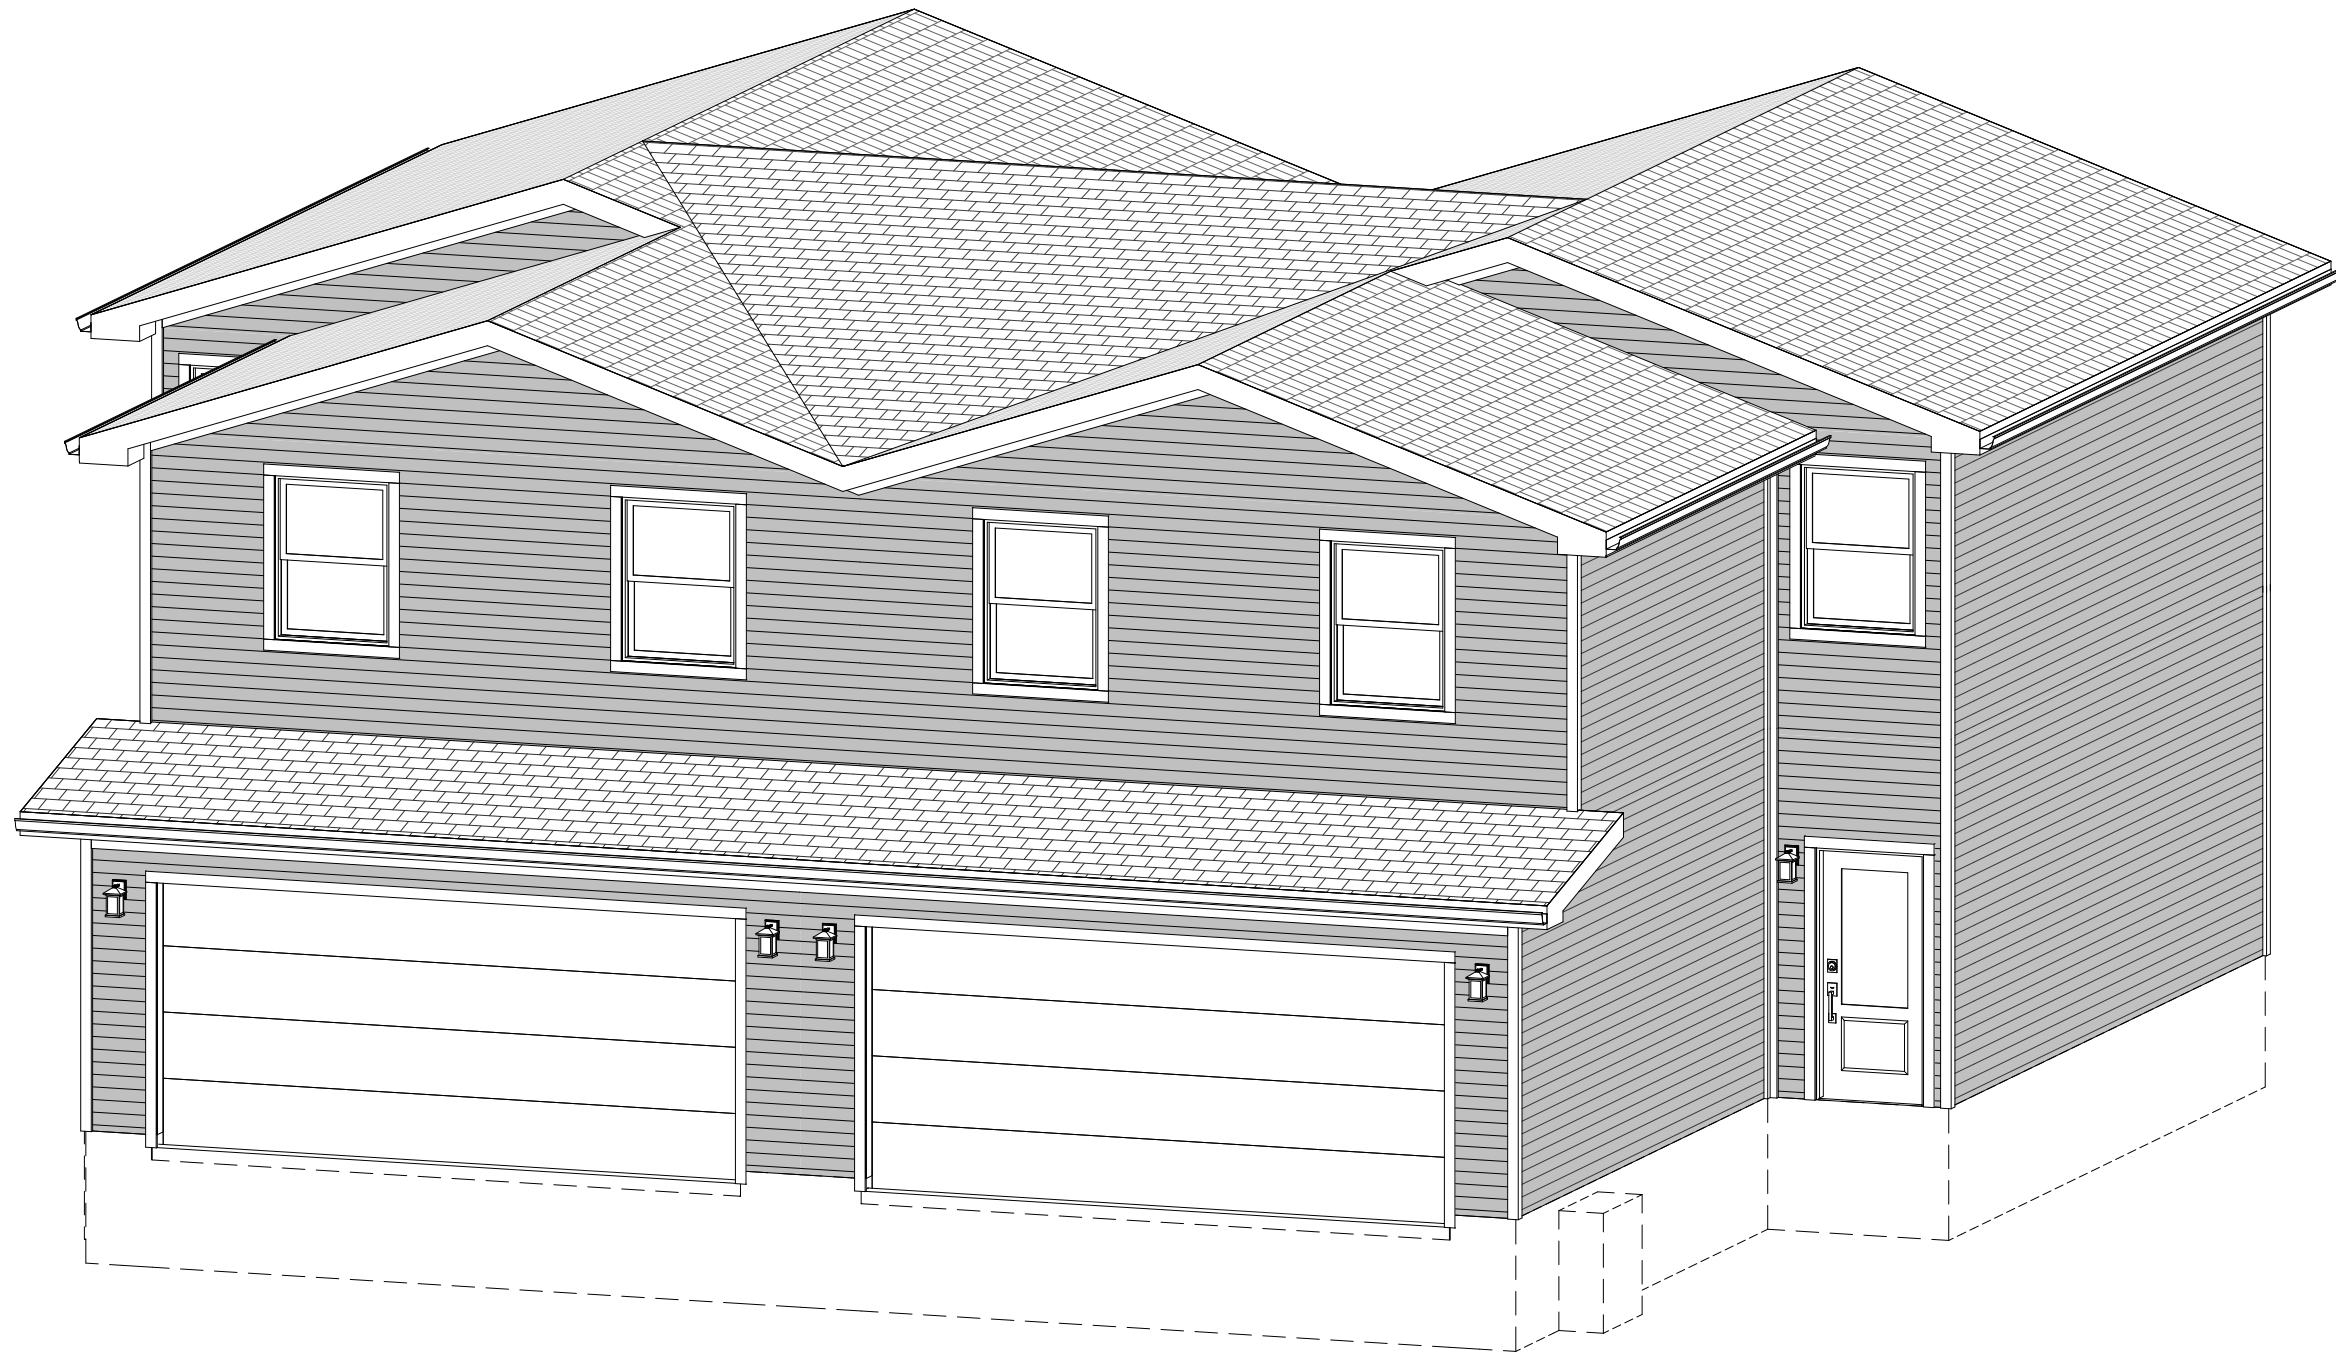

GENERAL PLAN NOTES

These working drawings have been prepared by VirtuActive, LLC to meet building conditions and were designed under standard interpretation of the 2018 International Residential Code (IRC 2018) and the amendments adopted by the local jurisdictions. Because codes and requirements can change and may vary from jurisdiction, VirtuActive, LLC cannot warrant compliance with any specific codes or regulations. Therefore, each individual contractor, sub-contractor, and supplier on the jobsite should consult their local building official to determine the appropriateness between the plan and actual jobsite conditions and applications.

CONCRETE and FOUNDATIONS:

Footing design assumes 1500 PSF allowable bearing pressure. Foundation wall designs assume 30 PSF equivalent hydrostatic pressure. Concrete contractor to verify soil conditions prior to concrete placement.

Re-enforcing footing as follows:

- Spread footings - as noted on plan
- Deck piers - as noted on plan

Anchor bolts must be spaced no more that 6' on center.

Once anchor bolt must be located not more than 12" from each end of the plate section

Contractors, sub-contractors, and suppliers shall be aware of and responsible for, but not limited to, the following:

- Contractors, sub-contractors, and suppliers shall verify all conditions and dimensions prior to construction and be solely responsible for any changes necessary as a result of conditional or dimensional differences.
- Contractors, sub-contractors, and suppliers shall verify all dimensions and elevations against the plan and actual site conditions.
- Calculated dimensions take precedence over scaled dimensions.
- All dimensions are from framing edge, unless otherwise noted.

STRUCTURAL and FRAMING:

All structural member types, sizes, and spans shall be verified by the contractor, sub-contractor, and/or supplier.

All additional structural members required for specific framing techniques shall be sized by the contractor, sub-contractor, and/or supplier.

All steel pipe columns shall be 3.5", unless otherwise noted.

Ceiling joists, rafters and /or roof trusses shown per plan. Sizing, spans reinforcement locations, and depth to be verified by the contractor, sub-contractor, and/or supplier.

Provide bridging as required by code.

All perimeter headers over openings to be (2) 2x12, unless otherwise noted.

Provide double cripple studs under all LVL headers.

Wind bracing to be CS-WSP unless specified otherwise.

Penetrations though any structural member must be verified by engineer and/or structural supplier.

TABLE OF CONTENTS

PAGE 1	COVER PAGE
PAGE 2	FRONT AND REAR VIEWS
PAGE 3	LEFT AND RIGHT VIEWS
PAGE 4	3D ORTHOGRAPHIC VIEWS
PAGE 5	FOUNDATION PLAN
PAGE 6	MAIN FLOOR PLAN
PAGE 7	UPPER FLOOR PLAN
PAGE 8	ROOF PLAN
PAGE 9	DETAILS
PAGE 10	ELECTRICAL PLANS

FINISHED SQ. FT.

2ND FLOOR	901 SF
MAIN LEVEL	606 SF
TOTALS	1507 SF

UNFINISHED SQ. FT.

GARAGE	386 SF
PATIO	120 SF
TOTALS	506 SF

These drawings are the proprietary work product and property of VirtuActive, LLC developed for the exclusive use of VirtuActive, LLC. Use of these drawings and concepts contained herein without the written permission of VirtuActive, LLC is prohibited. The contractor, sub-contractor, supplier, and/or homeowner shall verify all dimensions and specifications shown on these drawings against the actual site conditions. The contractor, sub-contractor, supplier, and/or homeowner must check all dimensions and other details prior to construction and be solely responsible for any discrepancies. Contractor, sub-contractor, and supplier are responsible for all code and regulatory requirements. VirtuActive, LLC is not responsible for any errors or omissions or for negligence on the jobsite due to lack of knowledge or lack of plan detail from the sub-structural members, site suitability, and dimensions shall be verified by the contractor, sub-contractor, supplier, and/or owner.

PROJECT LOCATION:
ADDRESS

PREPARED FOR:
HOMESTEAD COMMUNITIES
DUPLEX
Client Name


VIRTUACTIVE
VirtuActive - 3D Drafting & Design
1414 North 208th Street, Suite 2, Elkhorn, NE 68022
www.VirtuActive.com | 402.979.8100

DATE:

10/7/2025

SHEET:


PAGE 1

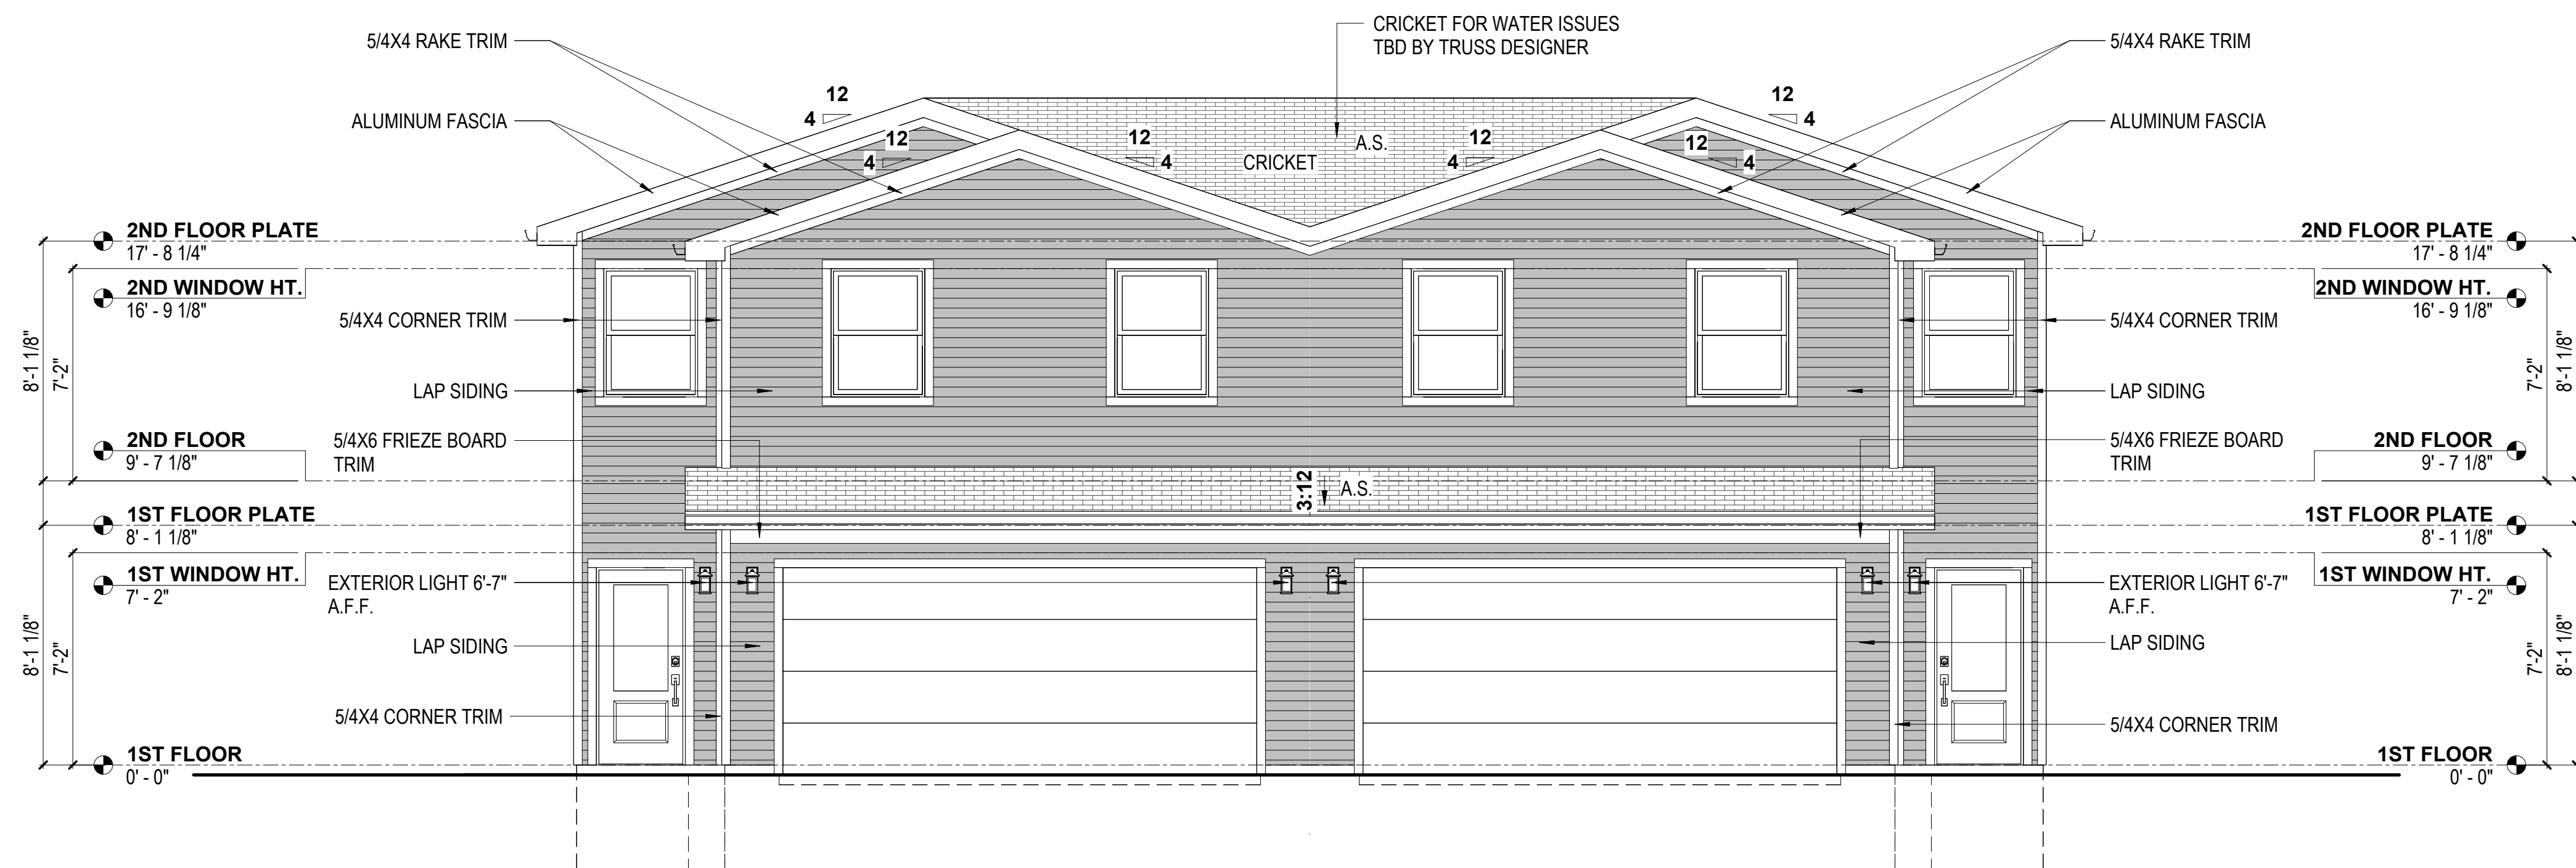

**TRANSITIONAL
FRONT VIEW**

1

1/4" = 1'-0"

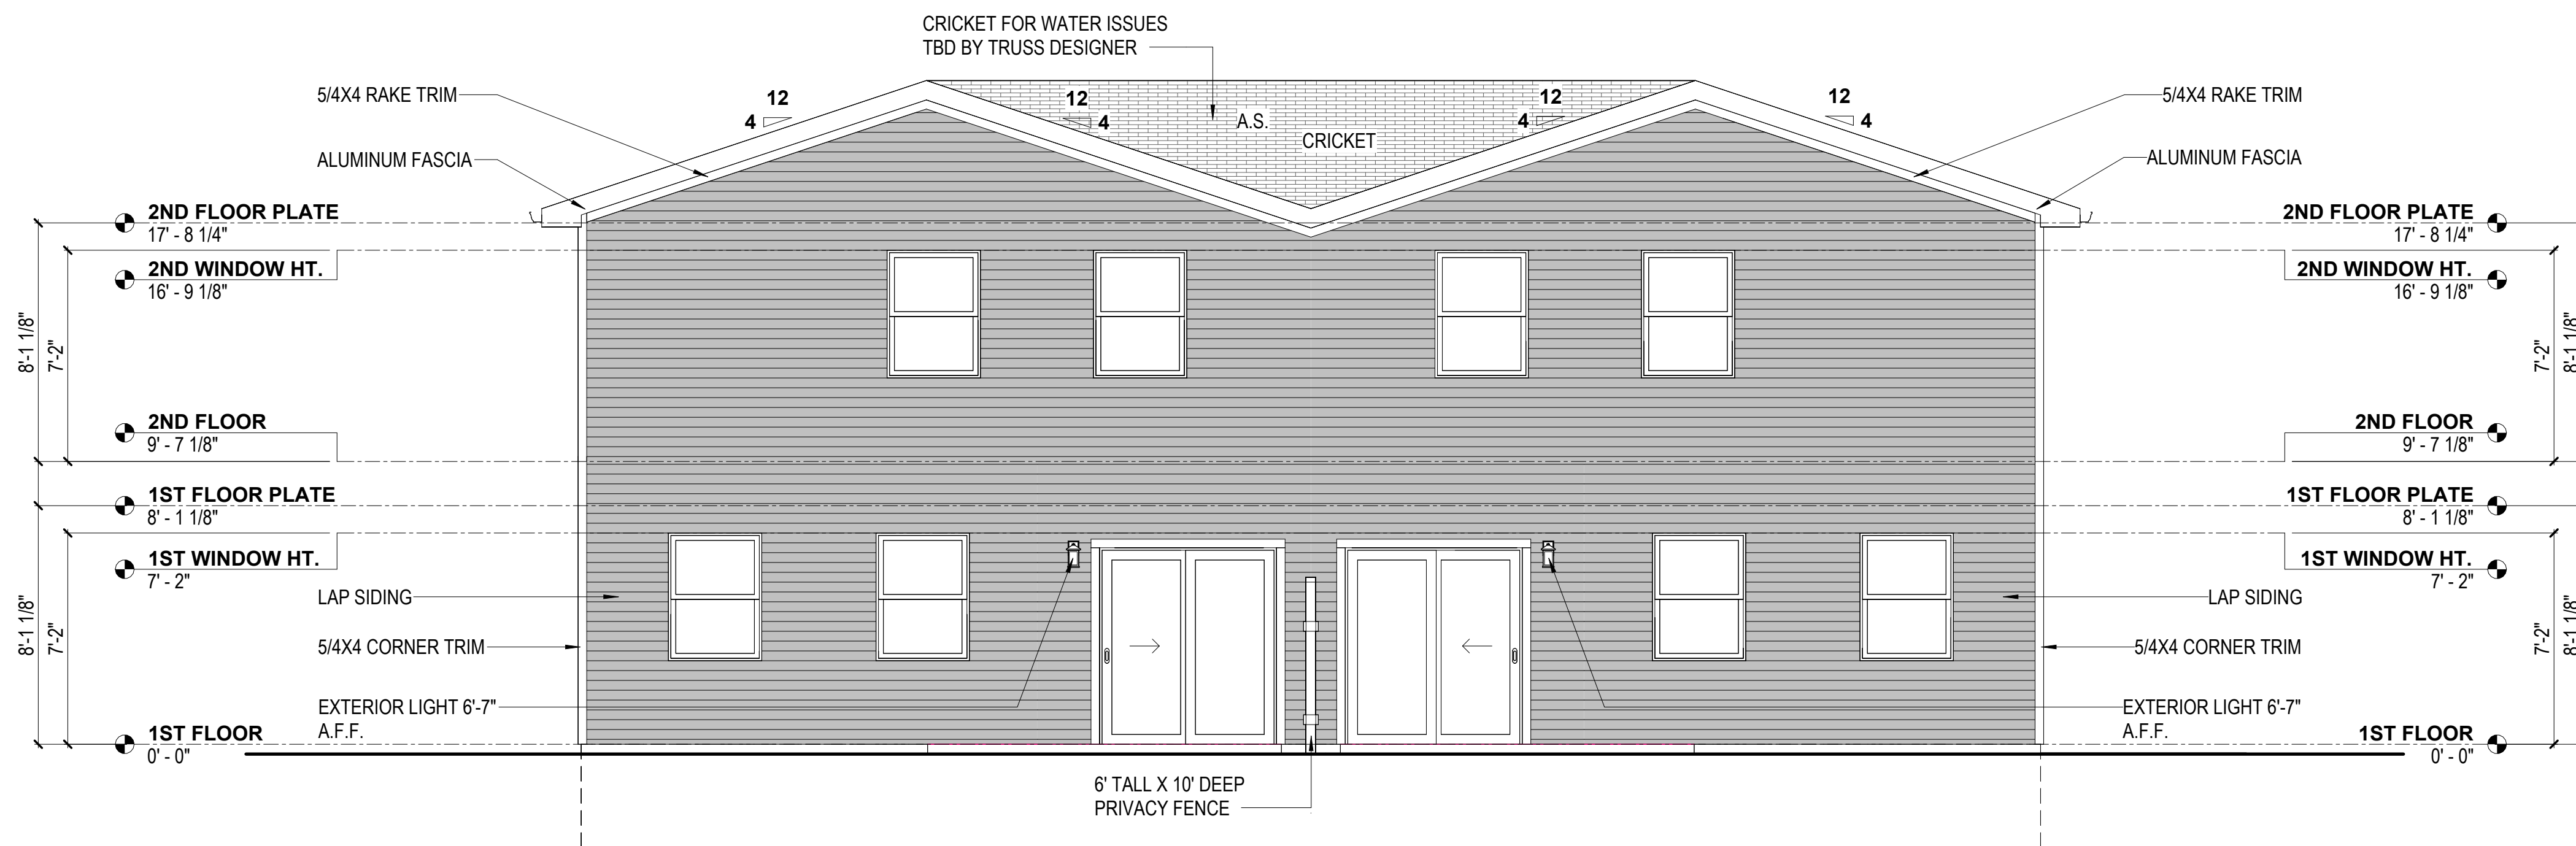

**TRANSITIONAL
REAR VIEW**

2

1/4" = 1'-0"

REVISION TABLE	DESCRIPTION
NUMBER	DATE

These drawings are the property of VirtuActive, LLC and are not to be reproduced, copied, or used in any way without the written permission of VirtuActive, LLC. Use of these drawings and concepts contained herein without the written permission of VirtuActive, LLC is prohibited. The contractor, sub-contractors, suppliers, and/or homeowners shall verify all dimensions and materials shown on these drawings. The contractor, sub-contractors, suppliers, and/or homeowners must check all dimensions and other details prior to construction and be solely responsible for any discrepancies. VirtuActive, LLC and its designers are not responsible for any code and safety for negligence on the jobsite due to lack of knowledge or lack of plan detail from the sub-contractors, suppliers, and/or homeowners. Dimensions shall be verified by the contractor, sub-contractors, suppliers, and/or homeowners.

PROJECT LOCATION:

ADDRESS

PREPARED FOR:

HOMESTEAD COMMUNITIES

DUPLEX

Client Name

VIRTUACTIVE

VirtuActive - 3D Drafting & Design

1414 North 20th Street, Suite 2, Elkhorn, NE 68022

www.VirtuActive.com | 402.979.8100

DATE:




10/7/2025

SHEET:

PAGE 2



PRELIMINARY PLANS,
NOT FOR CONSTRUCTION

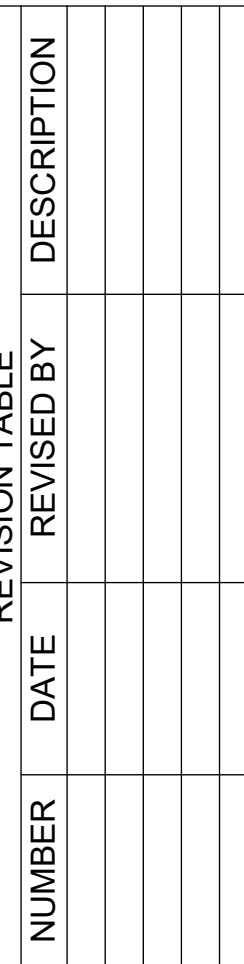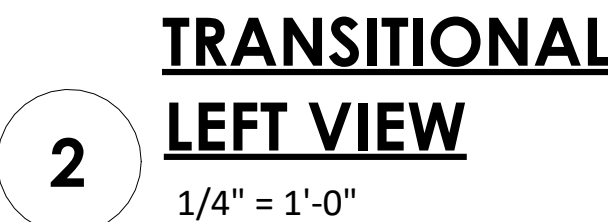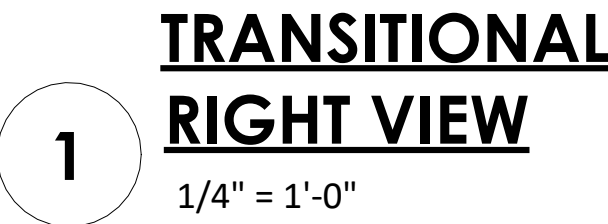

To the best of our knowledge these plans are drawn to comply with specific instructions. The contractor, sub-contractors, suppliers, and/or homeowners shall verify all dimensions and enclosed drawings. Each individual contractor, sub-contractor and supplier on the job must check all dimensions and other details prior to construction and be solely responsible thereafter. Contractors, sub-contractors, and suppliers are responsible for all code and regulatory requirements. The contractor, sub-contractor, and supplier shall be held responsible for negligence on the job site due to lack of knowledge or lack of care detail from the sub-contractor. The contractor is not an architect or engineer. Size, spacing, and location of structural members, site suitability, and dimensions shall be verified by the contractor, sub-

PROJECT LOCATION:






PREPARED FOR:

VirtuActive
1414 North 205th Street, Suite 2, Elkhorn, NE 68022
www.VirtuActive.com | 402.979.8100

DATE:
10/7/2025
SHEET:
PAGE 3

3D ORTHOGRAPHIC VIEWS

SCALE:

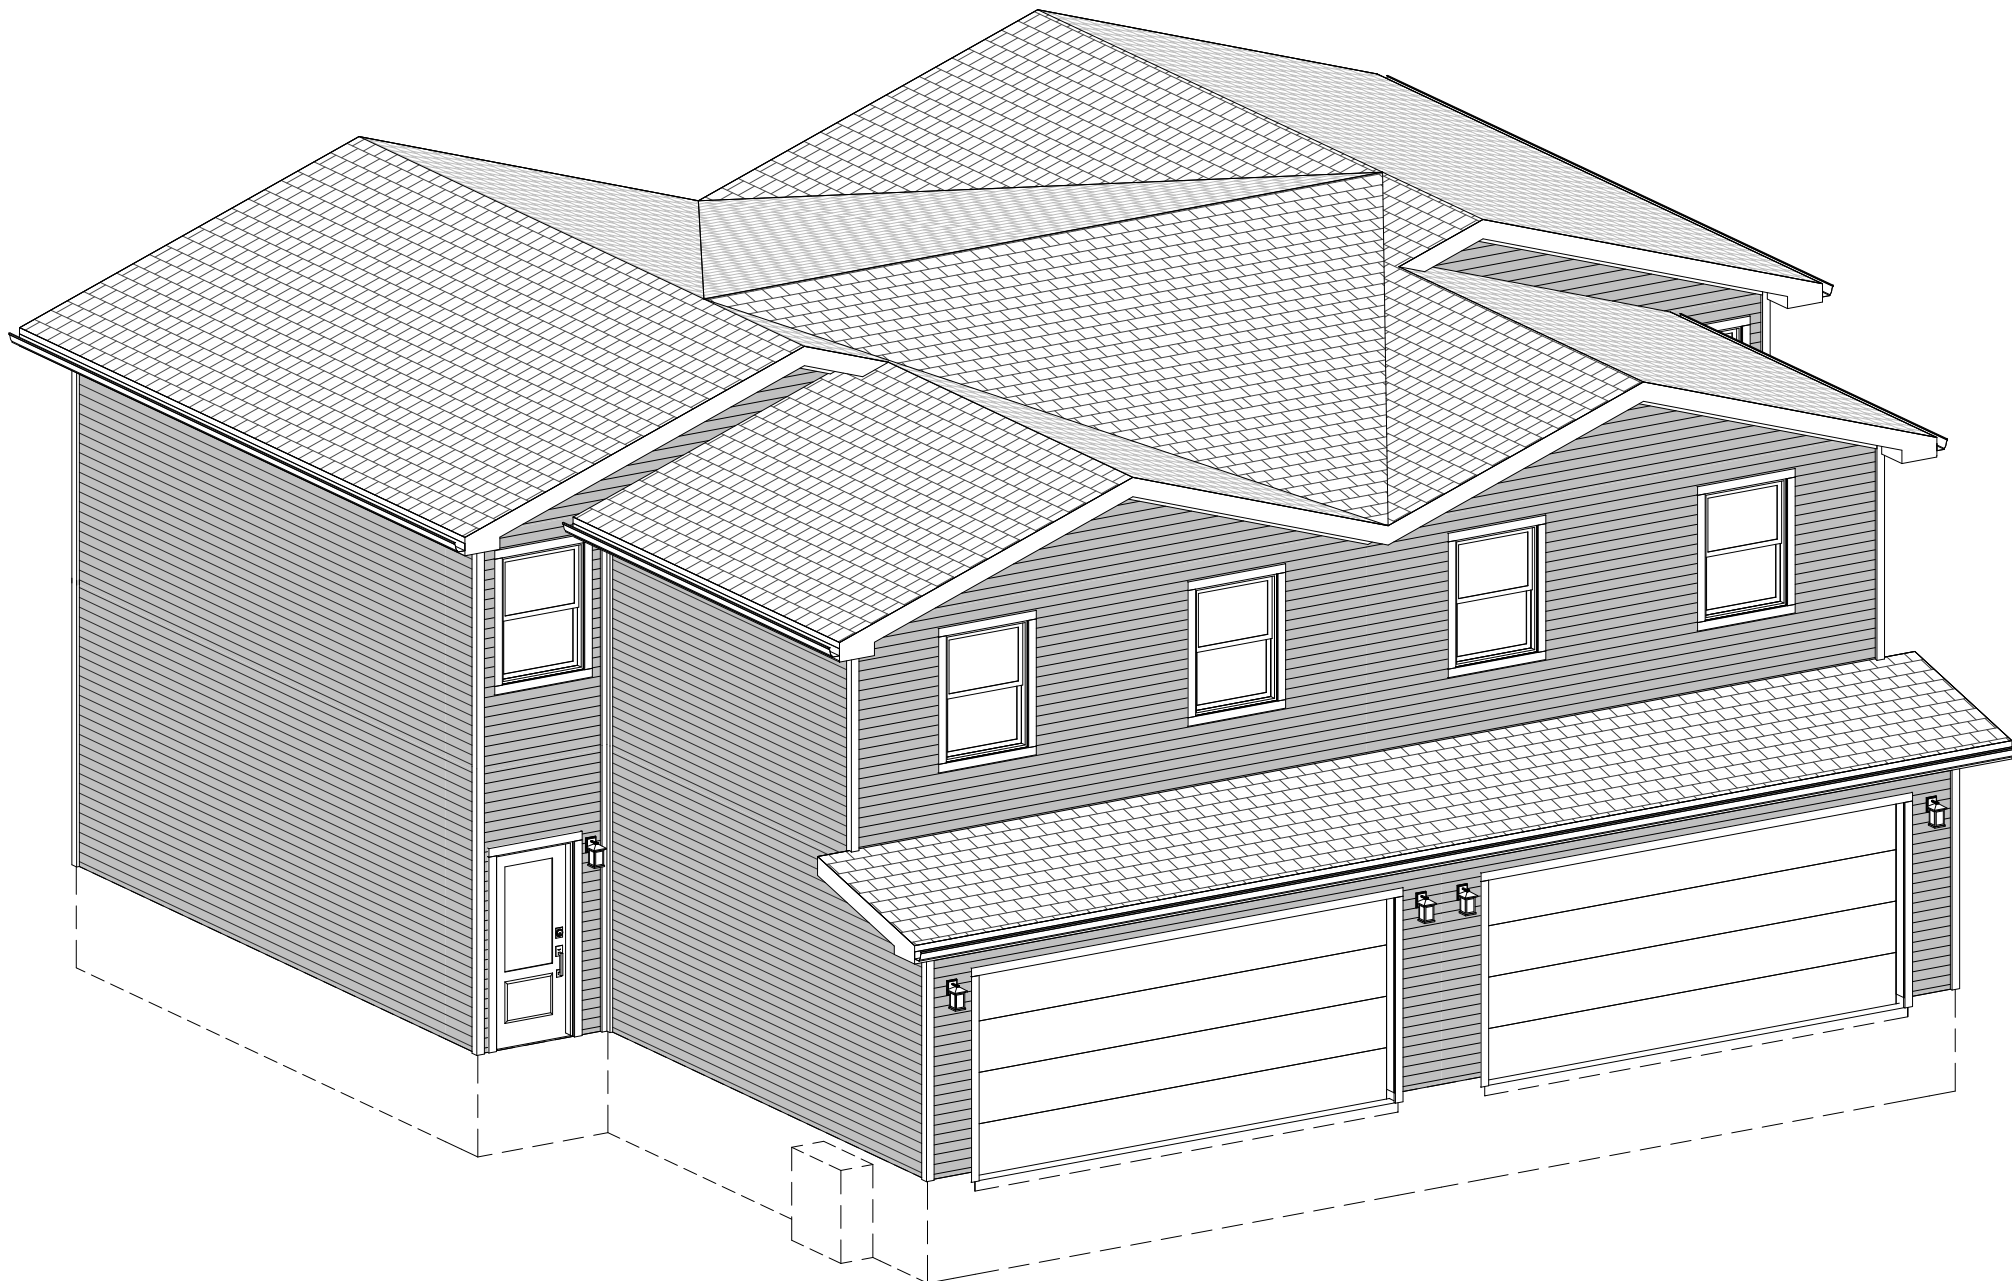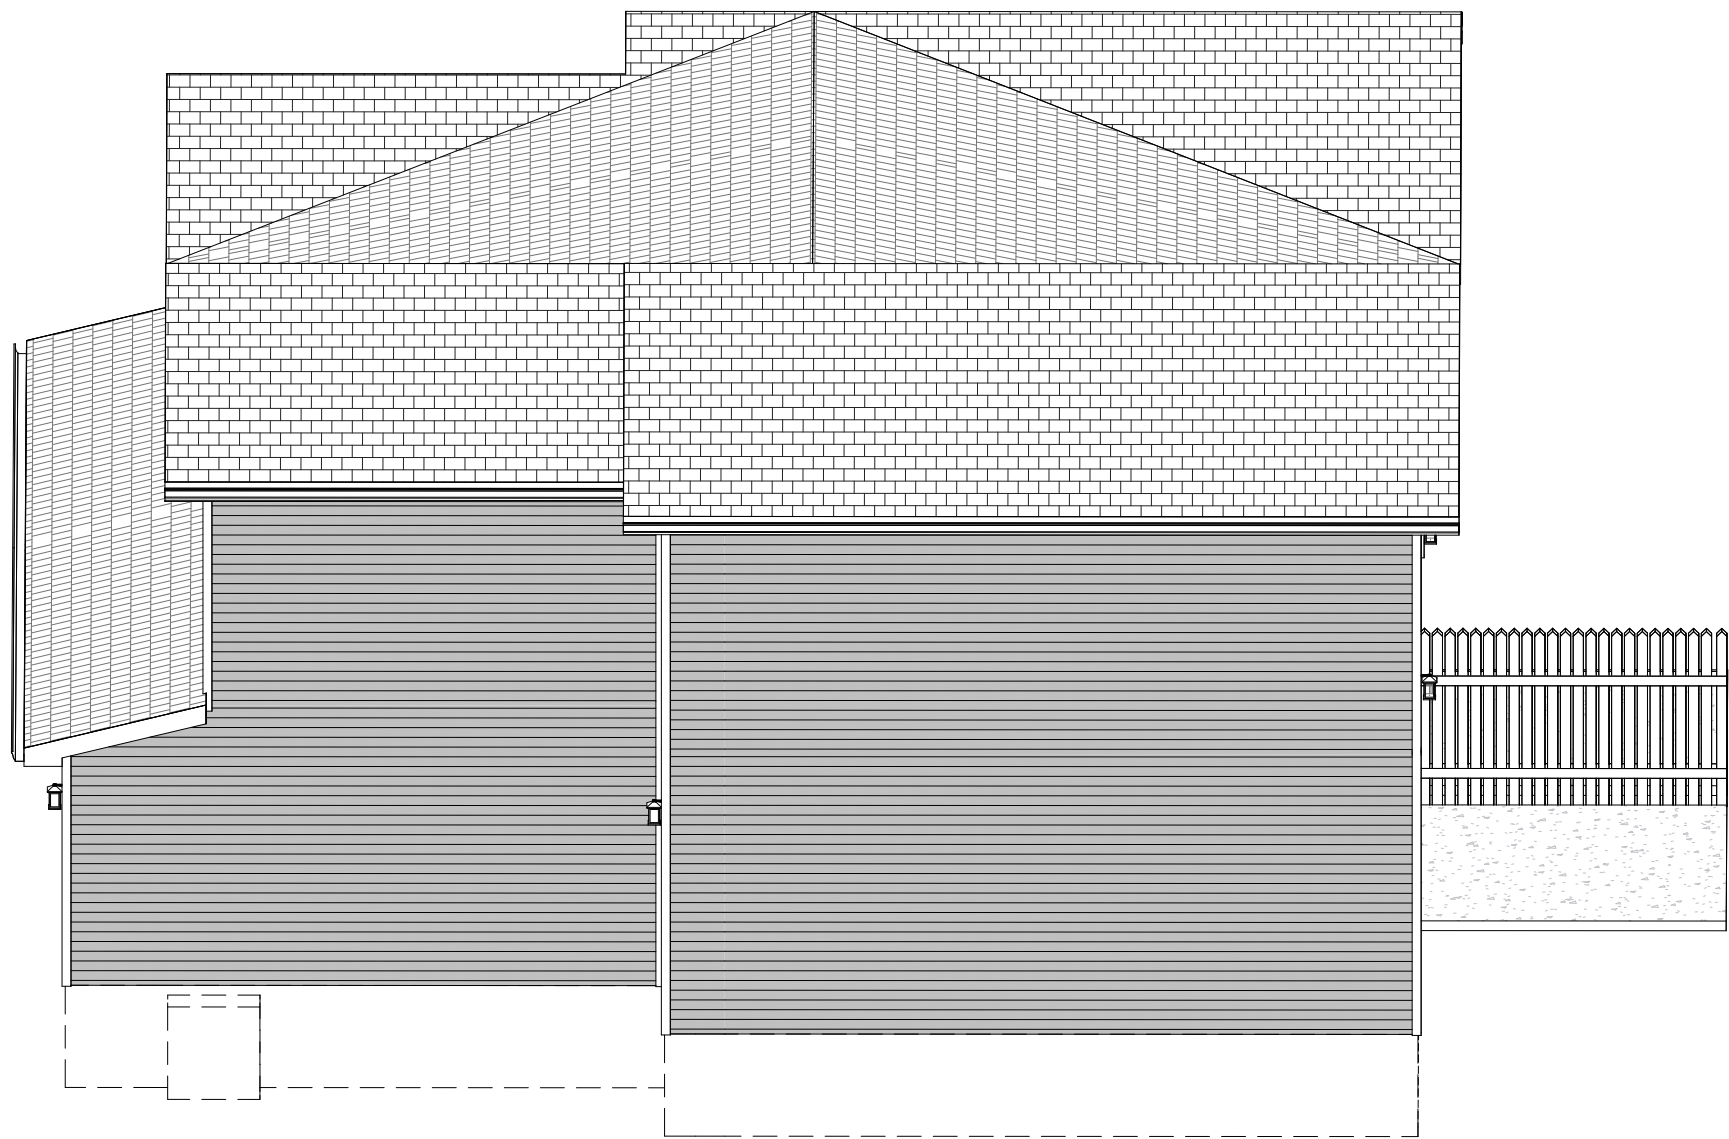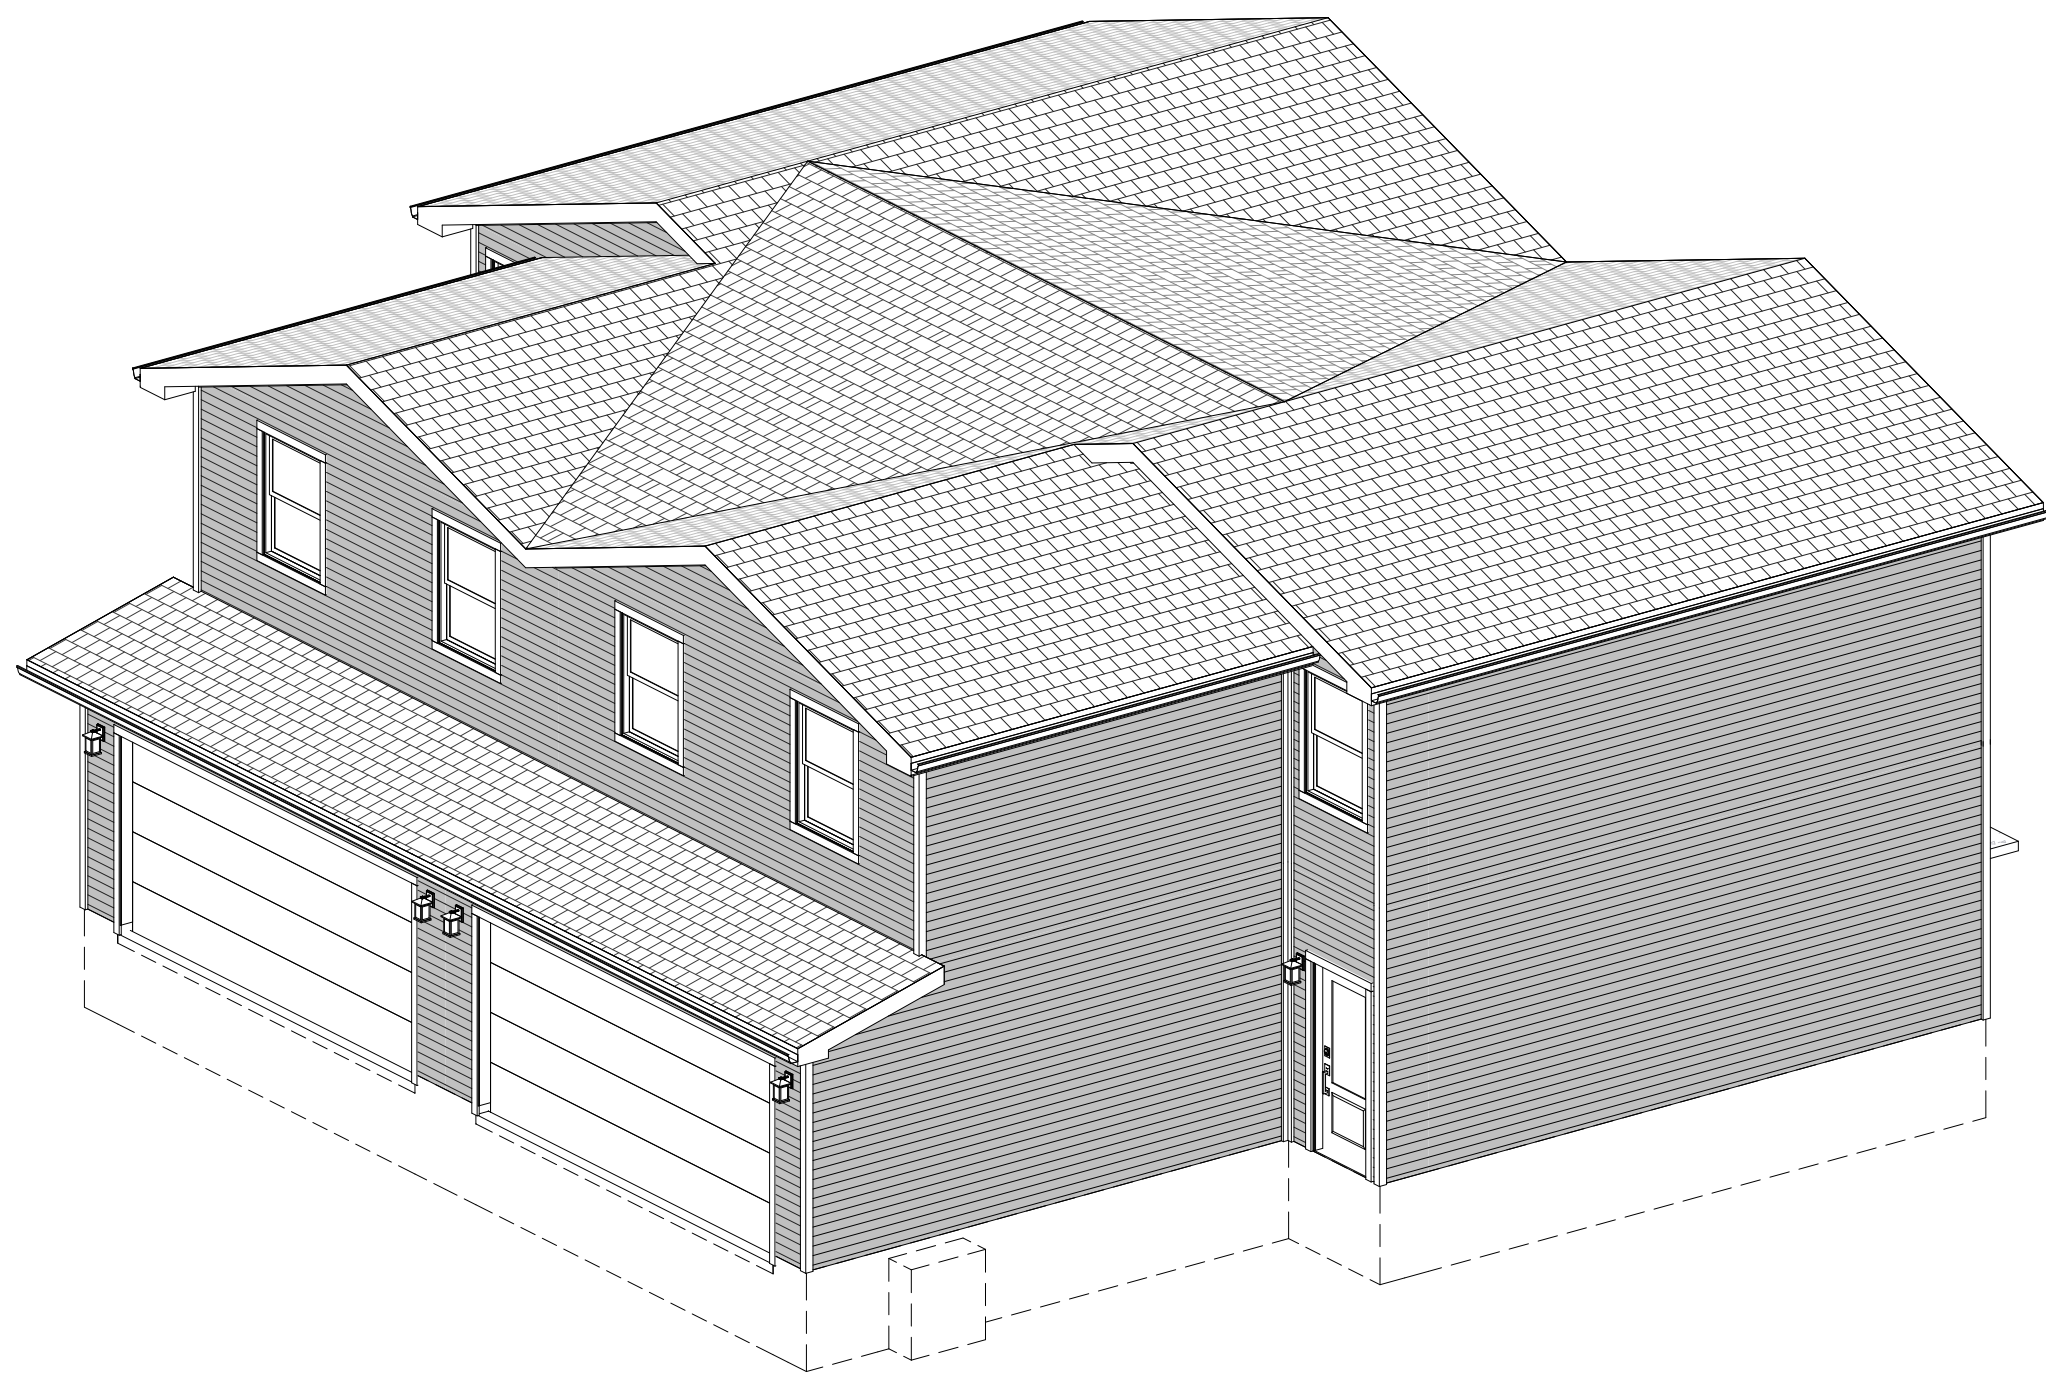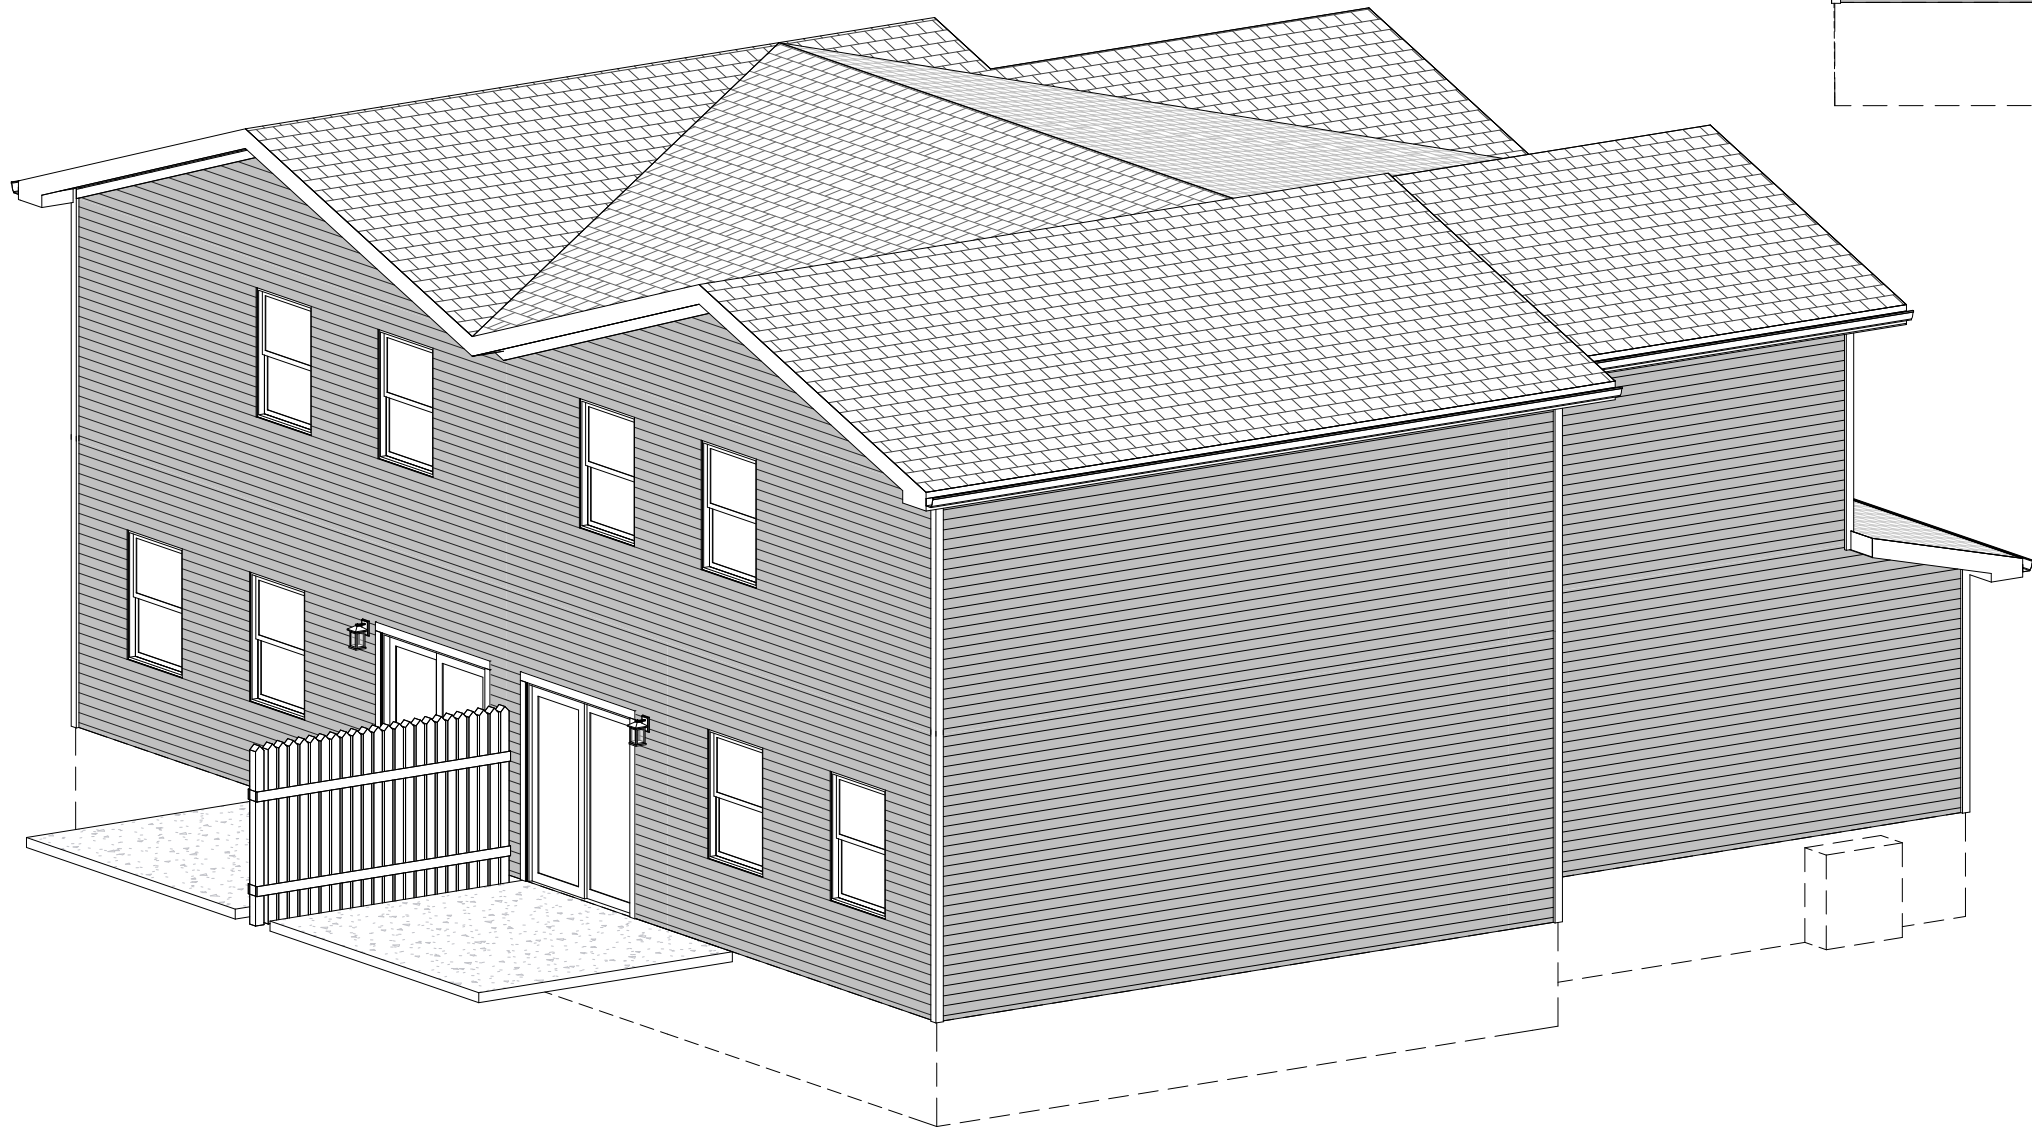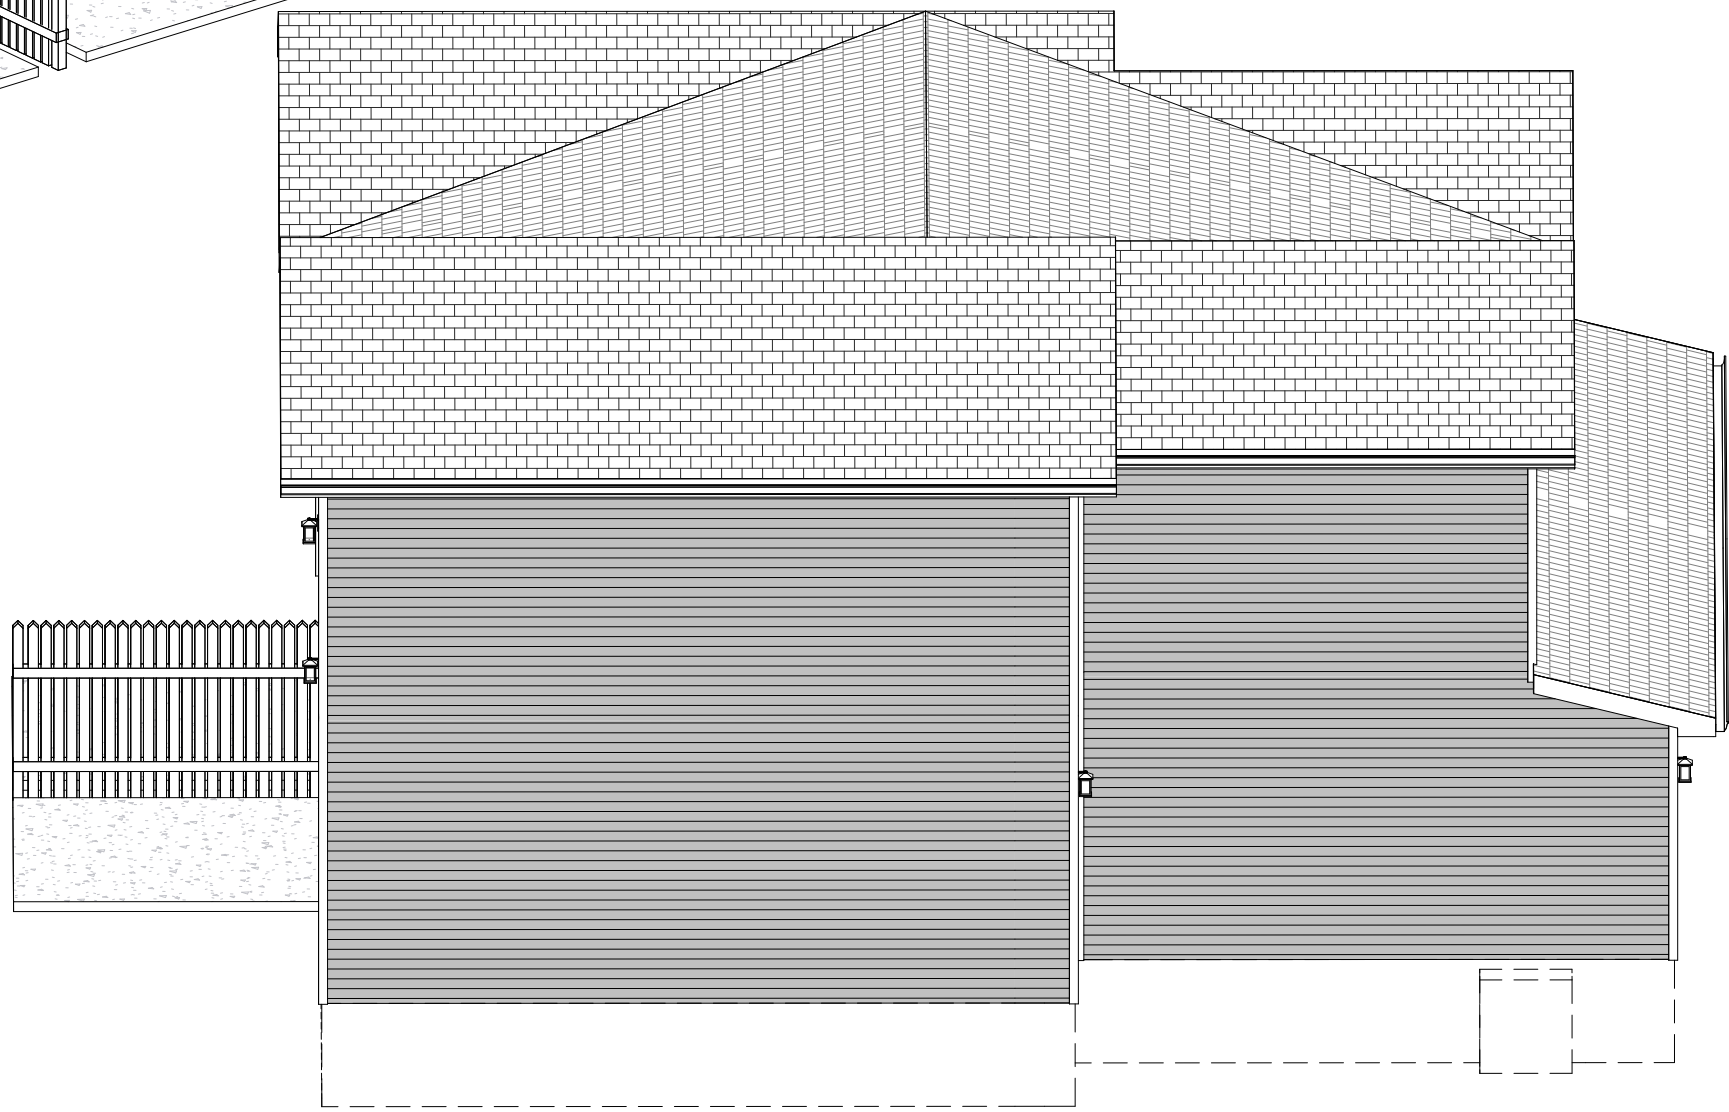

These drawings are the property of VirtuActive, LLC and are not to be reproduced or used in any way without the written permission of VirtuActive, LLC. Use of these drawings and concepts contained herein without the written permission of VirtuActive, LLC is prohibited. The contractor, sub-contractors, suppliers, and/or homeowners shall verify all dimensions and materials shown on these drawings. The contractor, sub-contractors, suppliers, and/or homeowners must check all dimensions and other details prior to construction and be solely responsible for any discrepancies. Contractors, sub-contractors, and suppliers are responsible for all code and regulatory requirements. For negligence on the job due to lack of knowledge or lack of plan detail from the sub-contractors, suppliers, and/or homeowners, the contractor, sub-contractors, suppliers, and/or homeowners shall be held liable.

PREPARED FOR:

HOMESTEAD COMMUNITIES
DUPLEX
Client Name

PROJECT LOCATION:

ADDRESS

NUMBER	DATE	REVISION BY	DESCRIPTION



FOUNDATION & FRAMING NOTES

- # TRANSITIONAL FOUNDATION PLAN

FINISHED SQ. FT.UNFINISHED SQ. FT.

GARAGE	386 SF
PATIO	120 SF
TOTALS	506 SF

for the exclusive use of Virtuative, LLC. Use of these drawings and concepts contained therein without the written permission of Virtuative, LLC is prohibited.

To the best of our knowledge these plans are drawn to comply with owner's specifications and the contractor, sub-contractors, suppliers, and/or homeowners shall verify all dimensions and materials used in the construction of the project. Virtuative, LLC shall not be responsible for any errors or omissions that may occur. The contractor, sub-contractors, suppliers, and/or homeowners must check all dimensions and other details prior to construction for all code and governing body compliance and all engineering. Virtuative, LLC will not take responsibility for negligence on the job site due to lack of knowledge or lack of care detail from the sub-contractor, sub-contractors, suppliers, and/or homeowners. The contractor, sub-contractors, suppliers, and/or owner, shall verify all dimensions and materials used in the construction of the project.

PROJECT LOCATION:

ADDRESS

PREPARED FOR:

HOMESTEAD COMMUNITIES

COUPLEX
Client Needs



VIRTUACTIVE

VirtuActive - 3D Drafting & Design

414 North 205th Street, Suite 2, Elkhorn, NE 68022
www.VirtuActive.com | 402.979.8100

www.VirtuActive.com | 402.979.8100

www.VirtuActive.com | 402.979.8100

DATE:

10/7/2025

SHEET:

PAGE 5






PRELIMINARY PLANS,
NOT FOR CONSTRUCTION

DOOR SCHEDULE					
MARK	COUNT	SILL HEIGHT	WIDTH	HEIGHT	MODEL
D0	2	-0' - 4"	16' - 0"	7' - 0"	
D1	2	0' - 0"	3' - 0"	6' - 8"	
D2	2	0' - 0"	2' - 4"	6' - 8"	
D3	2	0' - 0"	5' - 0"	6' - 8"	Bypass
D4	2	0' - 0"	6' - 0"	6' - 8"	Sliding
D5	2	0' - 0"	2' - 6"	6' - 8"	
D6	2	0' - 0"	2' - 8"	6' - 8"	

WINDOW SCHEDULE					
MARK	COUNT	SILL HEIGHT	WIDTH	HEIGHT	MODEL
W1	4	2'-10"	3'-2"	4'-4"	4800 Series, Double Hung

FOUNDATION & FRAMING NOTES

1. All structural members and framing members shall be confirmed by contractor, sub-contractor, and/or supplier for size, spacing, and species to verify they meet local code requirements.
2. All exterior framing dimensions are to exterior face of sheathing.
3. All interior framing dimensions to framing edge, unless otherwise noted.
4. 12" x Min. 36" below grade poured concrete foundation walls, unless otherwise noted.
5. 2x6 exterior and 2x4 interior walls, unless otherwise noted.
6. All exterior headers shall be (2) 2x12, unless otherwise noted.
7. Door sizes noted as feet and inches.
8. Window sizes noted as inches. Contractor, sub-contractor, and/or suppliers to confirm window openings for egress, min. light, min. height, and ventilation requirements. Contractor and/or sub-contractor to go off of supplier provided rough opening sheet for all rough openings & sizes.
9. Ceiling Heights: 8'-1 1/8" Main Floor; 8'-1 1/8" Upper Floor per plan.
10. Allow for at least 3.5" from interior door rough openings to wall.
11. All angled walls are 45°, unless otherwise noted.
12. All centerline dimensions for fixtures should be double checked for field accuracy.
13. Wall bracing method = CS-WSP

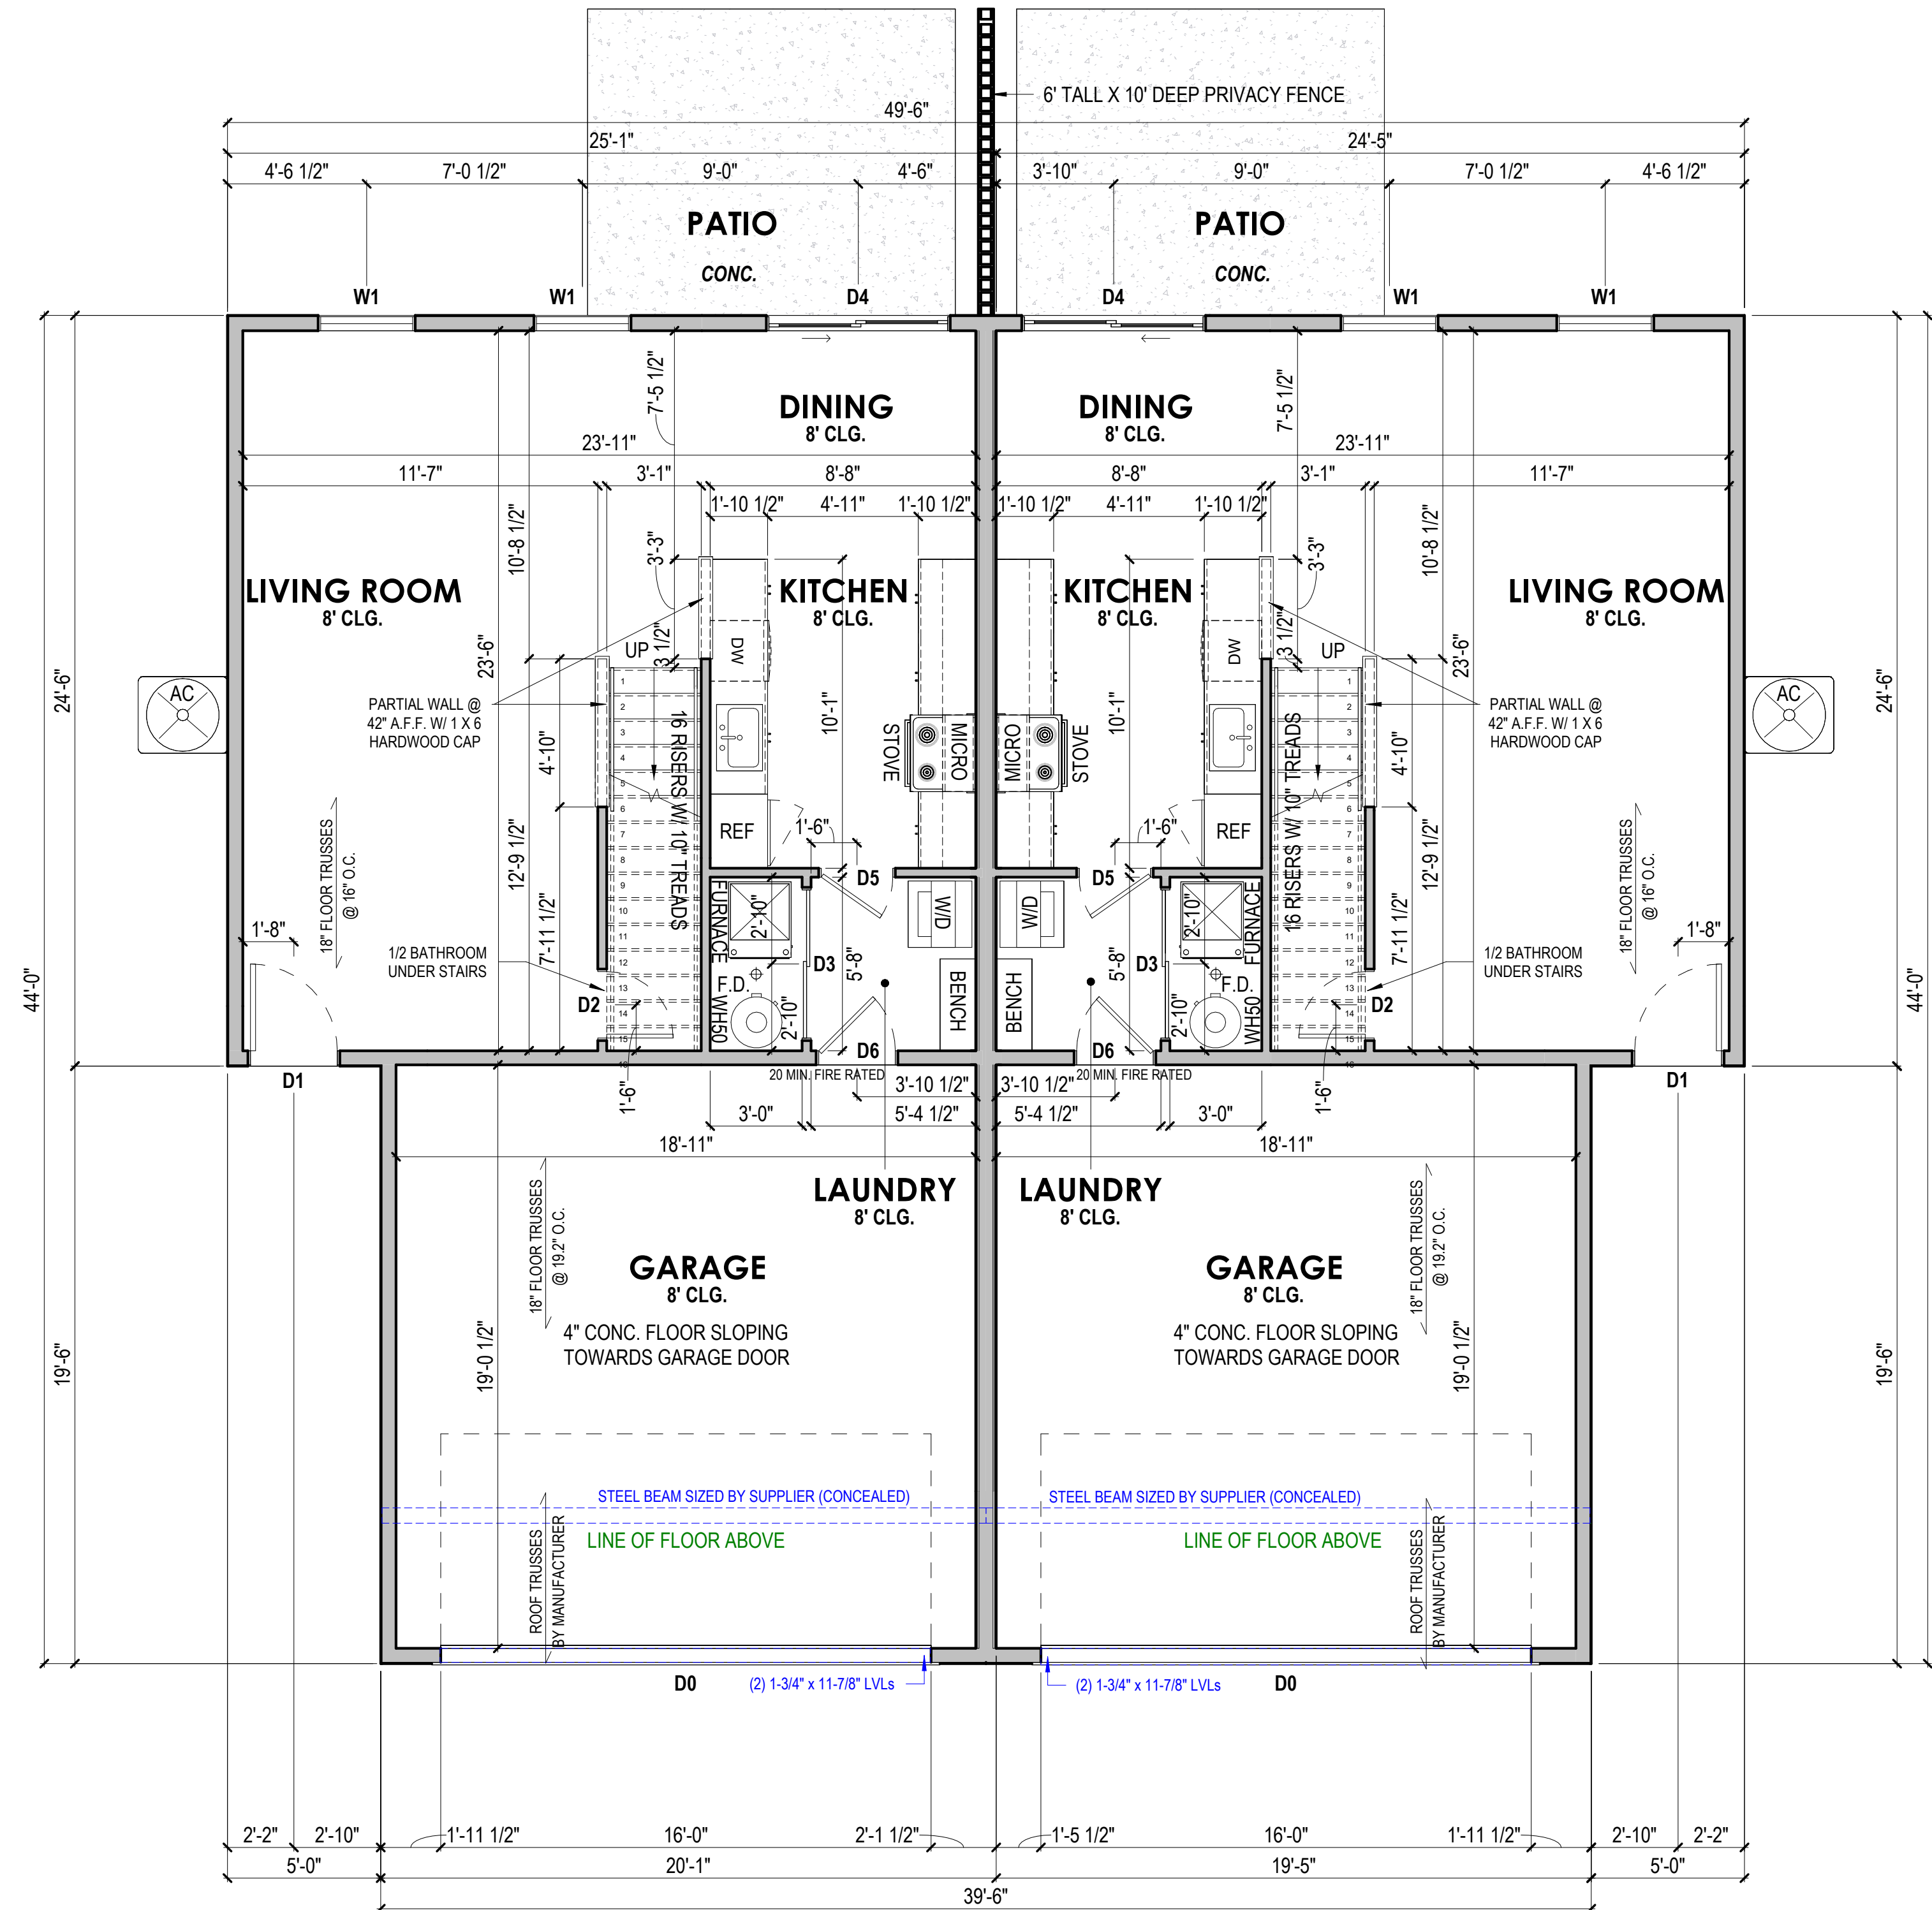

TRANSITIONAL 1ST FLOOR PLAN

$$1/4'' = 1'-0''$$

FINISHED SQ. FT.	
2ND FLOOR	901 SF
MAIN LEVEL	606 SF
TOTALS	1507 SF

UNFINISHED SQ. FT.	
GARAGE	386 SF
PATIO	120 SF
TOTALS	506 SF



REVISION TABLE		
NUMBER	DATE	REVISION BY

therein without the written permission of Vitacore, LLC. Use of these drawings and concepts contained in the contract, sub-contract, suppliers, and/or homeowners shall verify all specifications and dimensions with the architect and Vitacore, LLC. The contractor, sub-contractors, suppliers, and/or homeowners shall be responsible for maintaining check all dimensions and other details prior to construction and be solely responsible thereafter. Contractor, sub-contractors, and suppliers are responsible for all code and governing body compliance and all engineering. Vitacore, LLC will not take responsibility for negligence on the job site due to lack of knowledge. Lack of plan detail from the subcontractors, suppliers, and/or homeowners shall be the responsibility of the contractor, sub-contractors, suppliers, and/or homeowners.

PROJECT LOCATION:

ADDRESS

PREPARED FOR:

HOMESTEAD COMMUNITIES
DUPIX

Client Name

VIRTUACTIVE

VirtuActive - 3D Drafting & Design
414 North 205th Street, Suite 2, Elkhorn, NE 68022

www.VirtuActive.com | 402.979.8100

www.VirtuActive.com | 402.979.8100

DATE:

10/7/2025

SHEET:

PAGE 6




PRELIMINARY PLANS,
NOT FOR CONSTRUCTION

WINDOW SCHEDULE					
MARK	COUNT	SILL HEIGHT	WIDTH	HEIGHT	MODEL
W1	10	2' - 10"	3' - 2"	4' - 4"	4800 Series, Double Hung

FOUNDATION & FRAMING NOTES

1. All structural members and framing members shall be confirmed by contractor, sub-contractor, and/or supplier for size, spacing, and species to verify they meet local code requirements.
2. All exterior framing dimensions are to exterior face of sheathing.
3. All interior framing dimensions to framing edge, unless otherwise noted.
4. 12" x Min. 36" below grade poured concrete foundation walls, unless otherwise noted.
5. 2x6 exterior and 2x4 interior walls, unless otherwise noted.
6. All exterior headers shall be (2) 2x12, unless otherwise noted.
7. Door sizes noted as feet and inches.
8. Window sizes noted as inches. Contractor, sub-contractor, and/or suppliers to confirm window openings for egress, min. light, min. height, and ventilation requirements. Contractor and/or sub-contractor to go off of supplier provided rough opening sheet for all rough openings & sizes.
9. Ceiling Heights: 8'-1 1/8" Main Floor; 8'-1 1/8" Upper Floor per plan.
10. Allow for at least 3.5" from interior door rough openings to wall.
11. All angled walls are 45°, unless otherwise noted.
12. All centerline dimensions for fixtures should be double checked for field accuracy.
13. Wall bracing method = CS-WSP

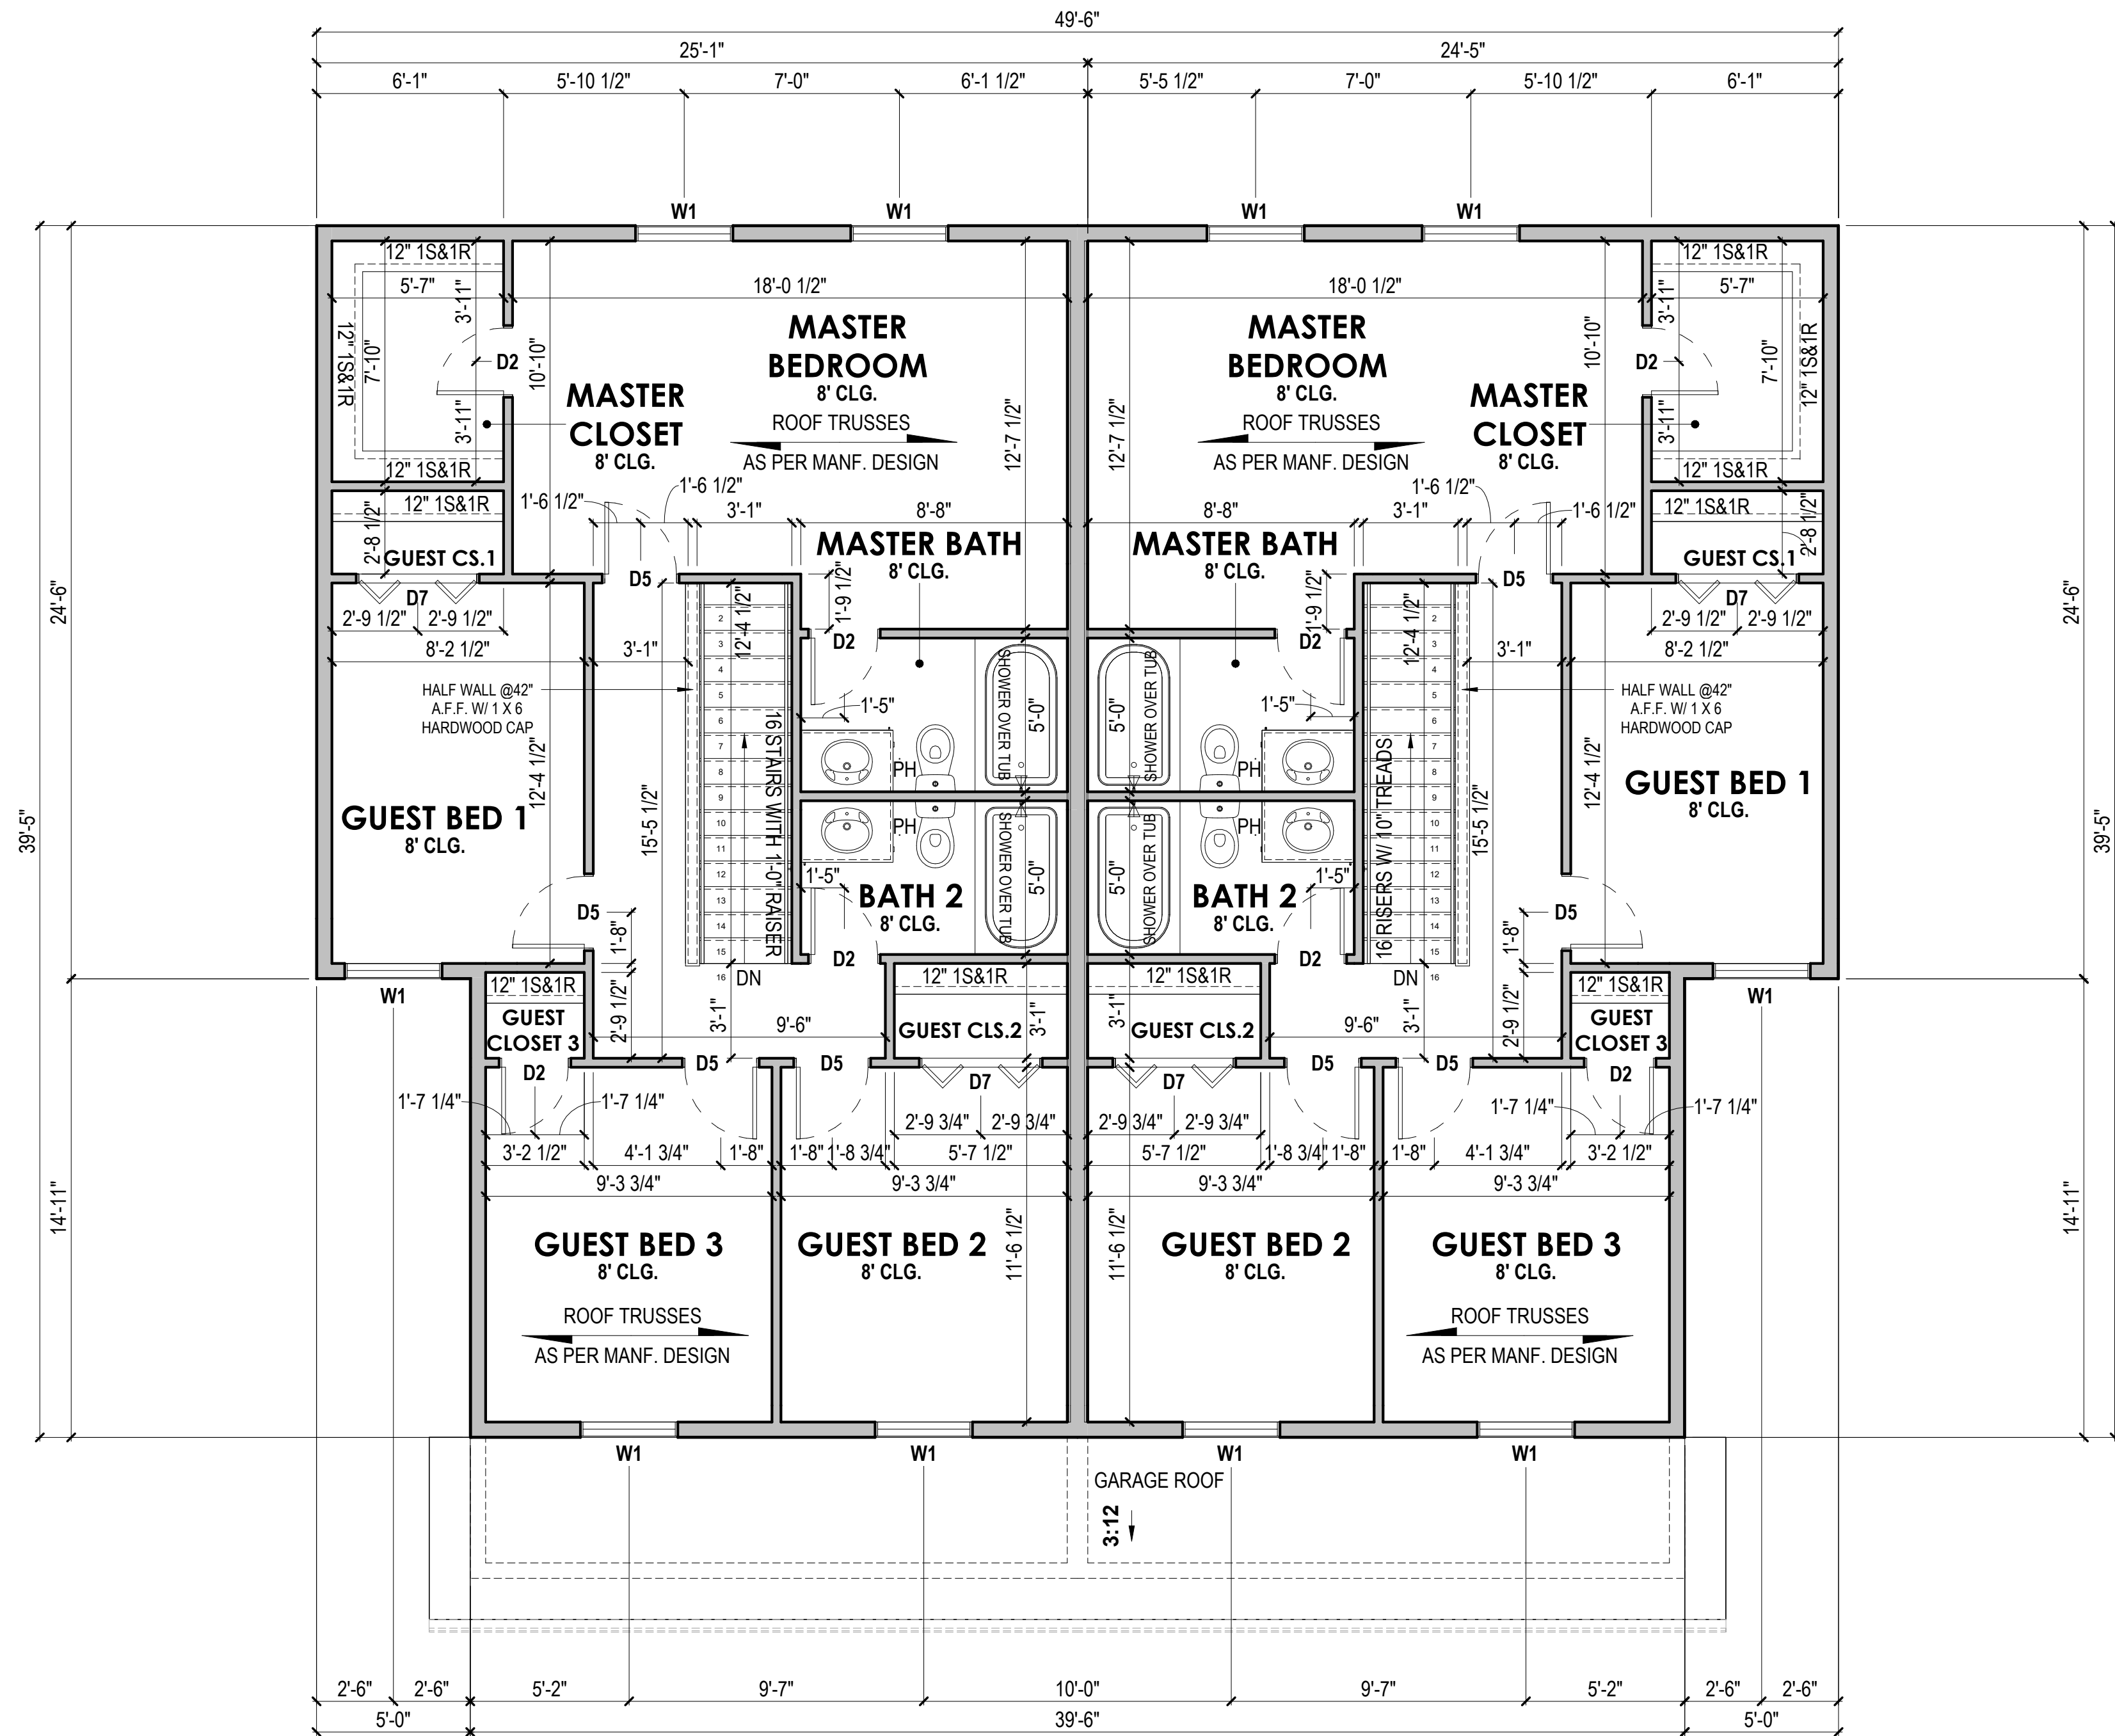

TRANSITIONAL 2ND FLOOR PLAN

$$1/4'' = 1'-0''$$

FINISHED SQ. FT.	
2ND FLOOR	901 SF
MAIN LEVEL	606 SF
TOTALS	1507 SF

UNFINISHED SQ. FT.	
GARAGE	386 SF
PATIO	120 SF
TOTALS	506 SF



REVISION TABLE		
NUMBER	DATE	REVISION BY DESCRIPTION

therein without the written permission of Vitacore, LLC. Use of these drawings and concepts contained in the contract, sub-contract, suppliers, and/or homeowners shall verify all specifications and dimensions with the architect and Vitacore, LLC. The contractor, sub-contractors, suppliers, and/or homeowners shall be responsible for making all necessary checks and dimensions and their details prior to construction and be solely responsible thereafter. Contractor, sub-contractors, and suppliers are responsible for all code and governing body compliance and all engineering. Vitacore, LLC will not take responsibility for negligence on the job site due to lack of knowledge. Lack of plan detail from the subcontractors, suppliers, and/or homeowners shall be the responsibility of the contractor, sub-contractors, suppliers, and/or homeowners.

PROJECT LOCATION:

ADDRESS

PREPARED FOR:

HOMESTEAD COMMUNITIES
DUPIX

Client Name

VIRTUACTIVE

VirtuActive - 3D Drafting & Design
414 North 205th Street, Suite 2, Elkhorn, NE 68022

www.VirtuActive.com | 402.979.8100

www.VirtuActive.com | 402.979.8100

DATE:

10/7/2025

SHEET:


PAGE 7




PRELIMINARY PLANS,
NOT FOR CONSTRUCTION



2 WALL SECTION
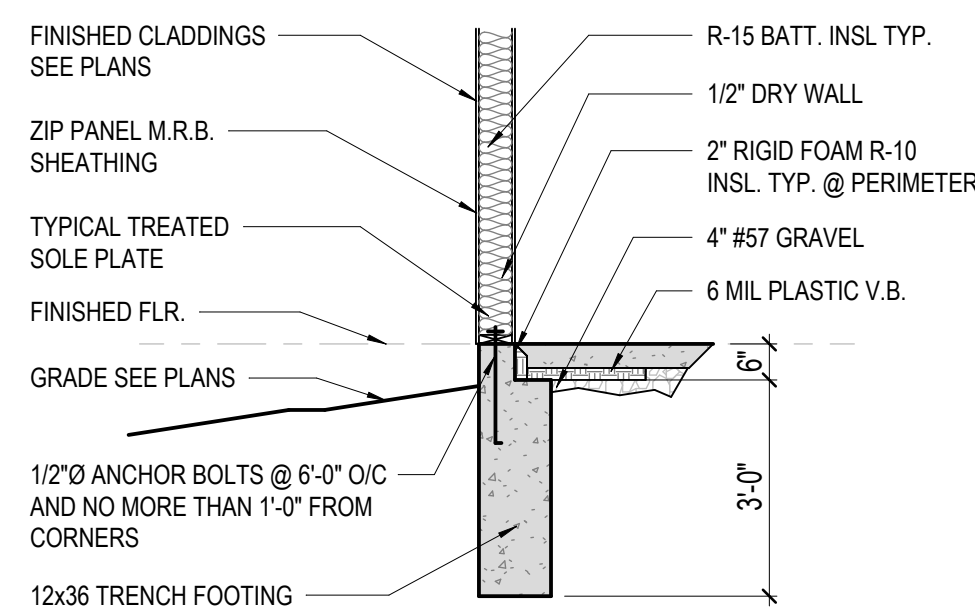
$$3/8'' = 1'-0''$$


3 GARAGE WALL SECTION
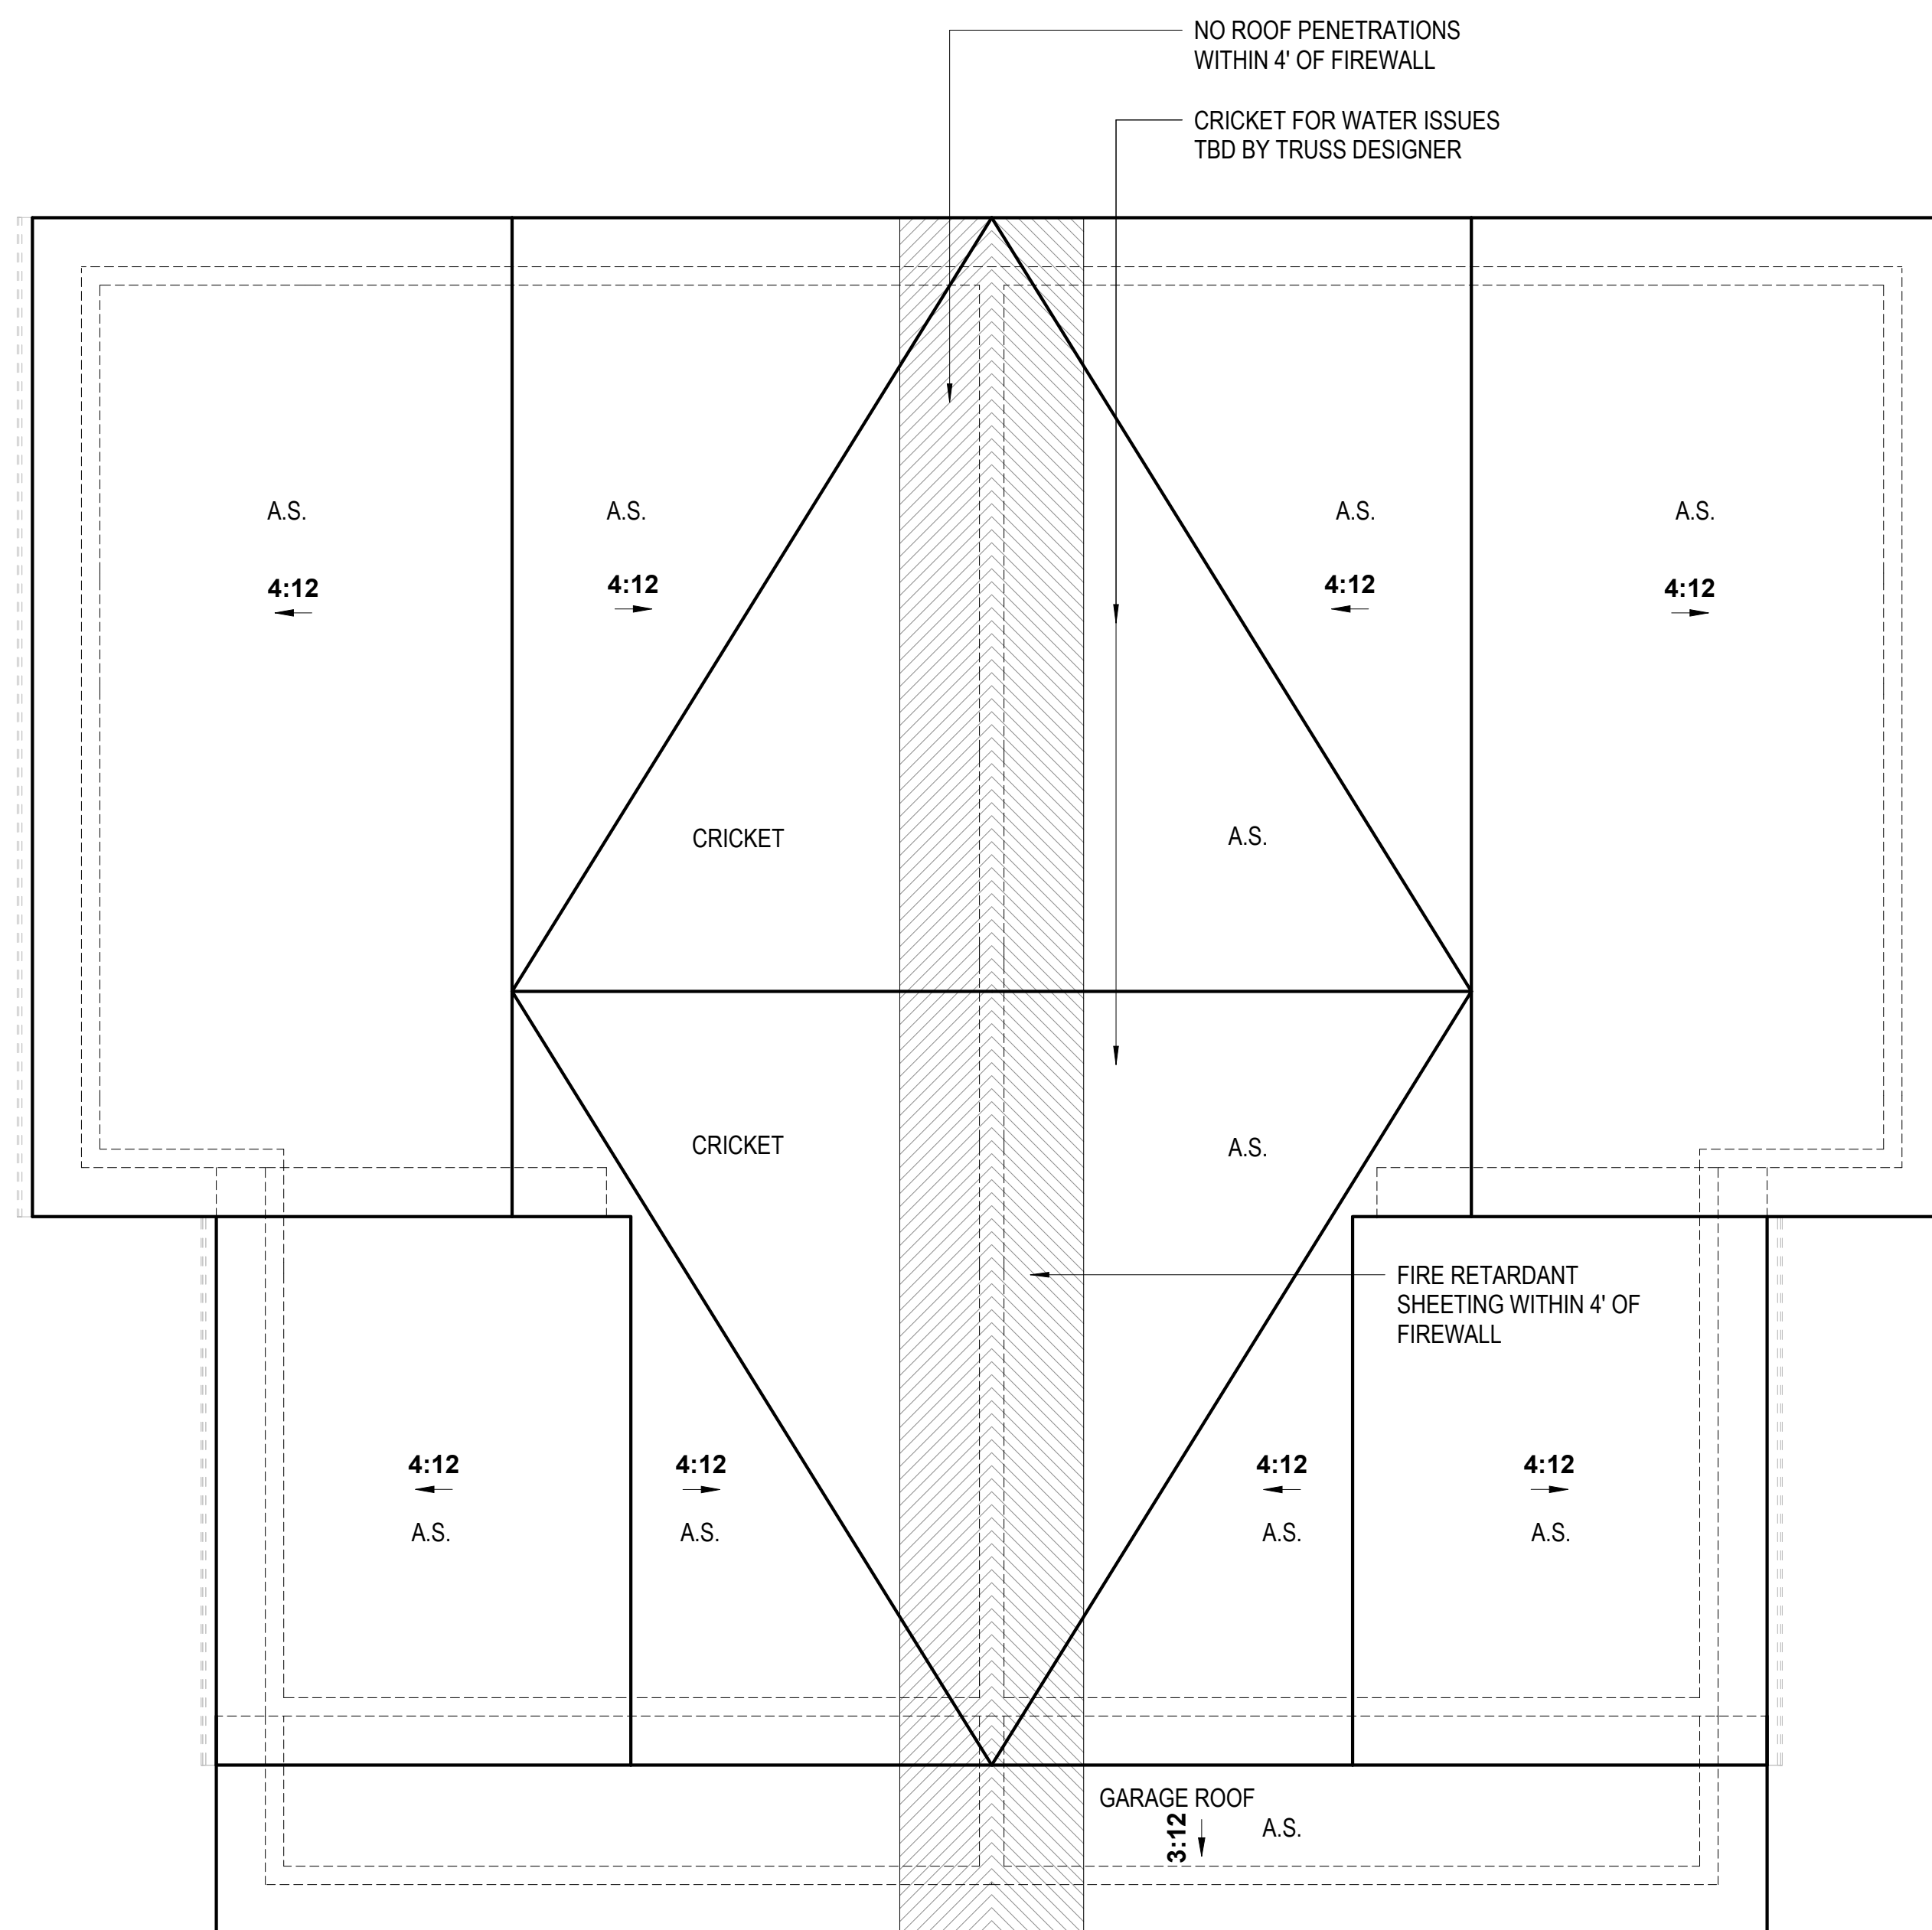
$$3/8'' = 1'-0''$$


TRANSITIONAL ROOF PLAN

$$1/4'' = 1'-0''$$

GABLE 1'-4" OVERHANG

PROJECT LOCATION:

PREPARED FOR:

VRTUACTIVE
VirtuActive - 3D Drafting & Design
1414 North 205th Street, Suite 2, Elkhorn, NE 68022
www.VirtuActive.com | 402.979.8100




DATE:
10/7/2025
SHEET:
PAGE 8






VIRTUACTIVE

PRELIMINARY PLANS,
NOT FOR CONSTRUCTION

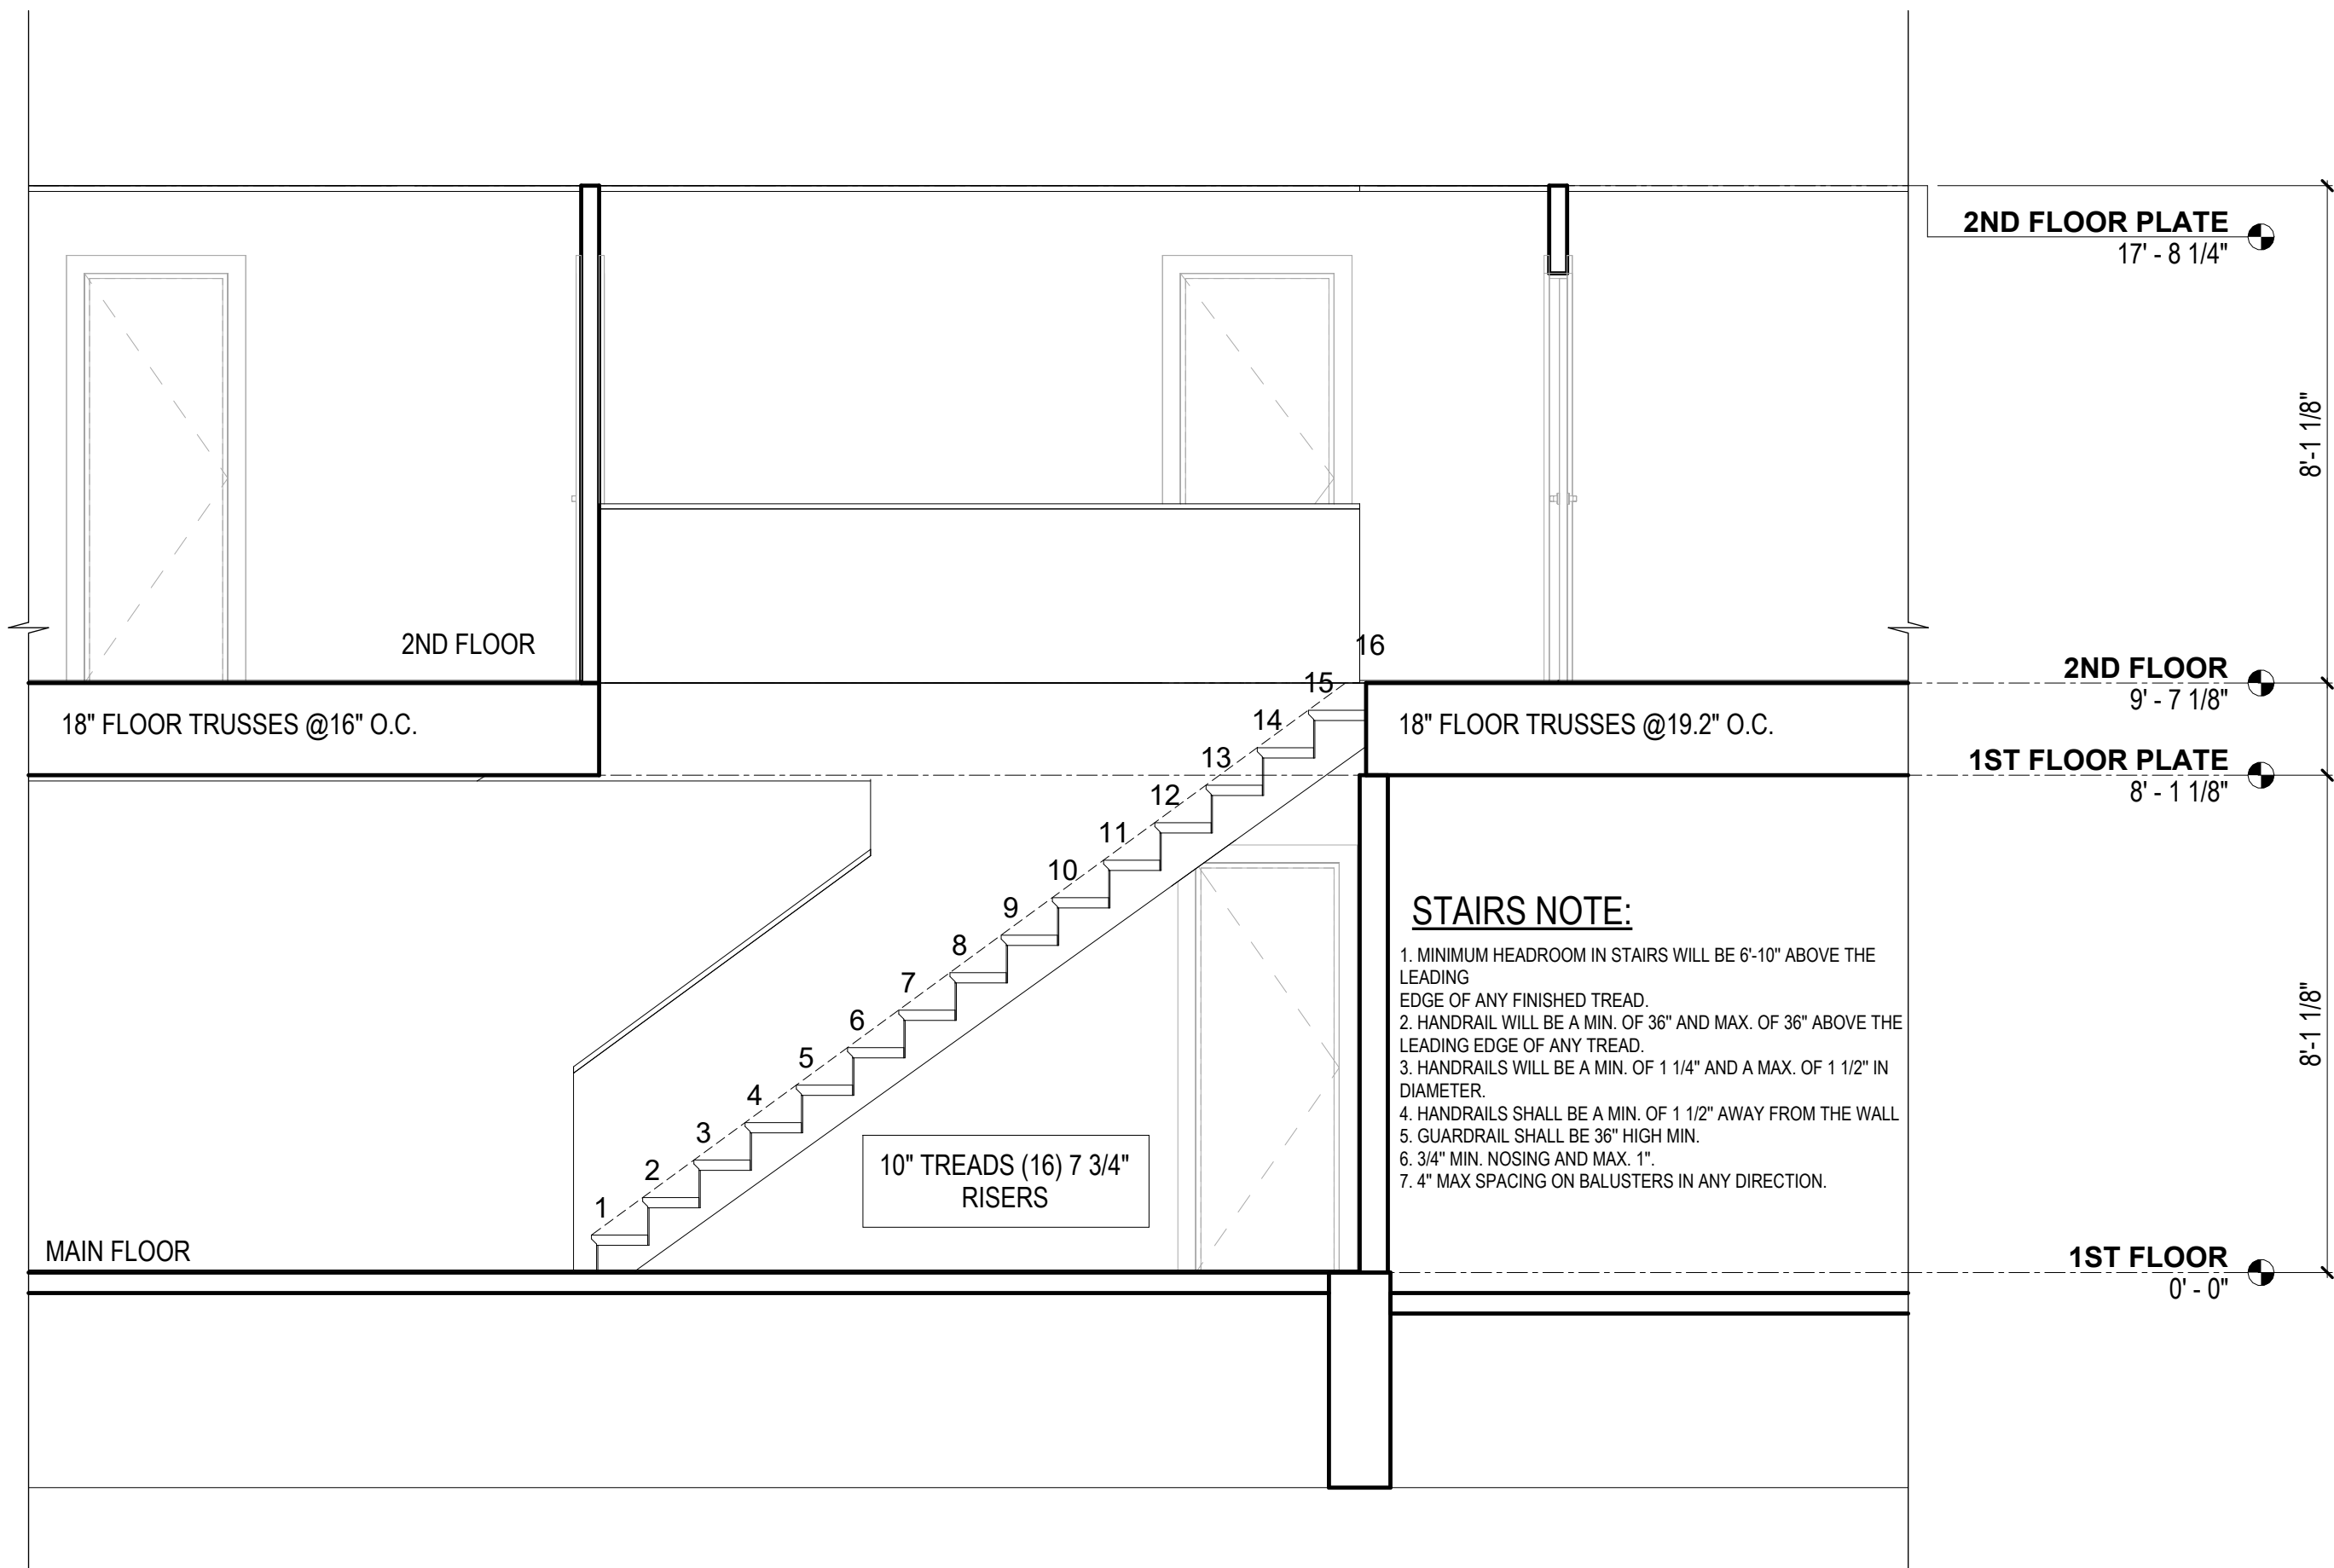

1 **STAIR DETAIL**
3/8" = 1'-0"

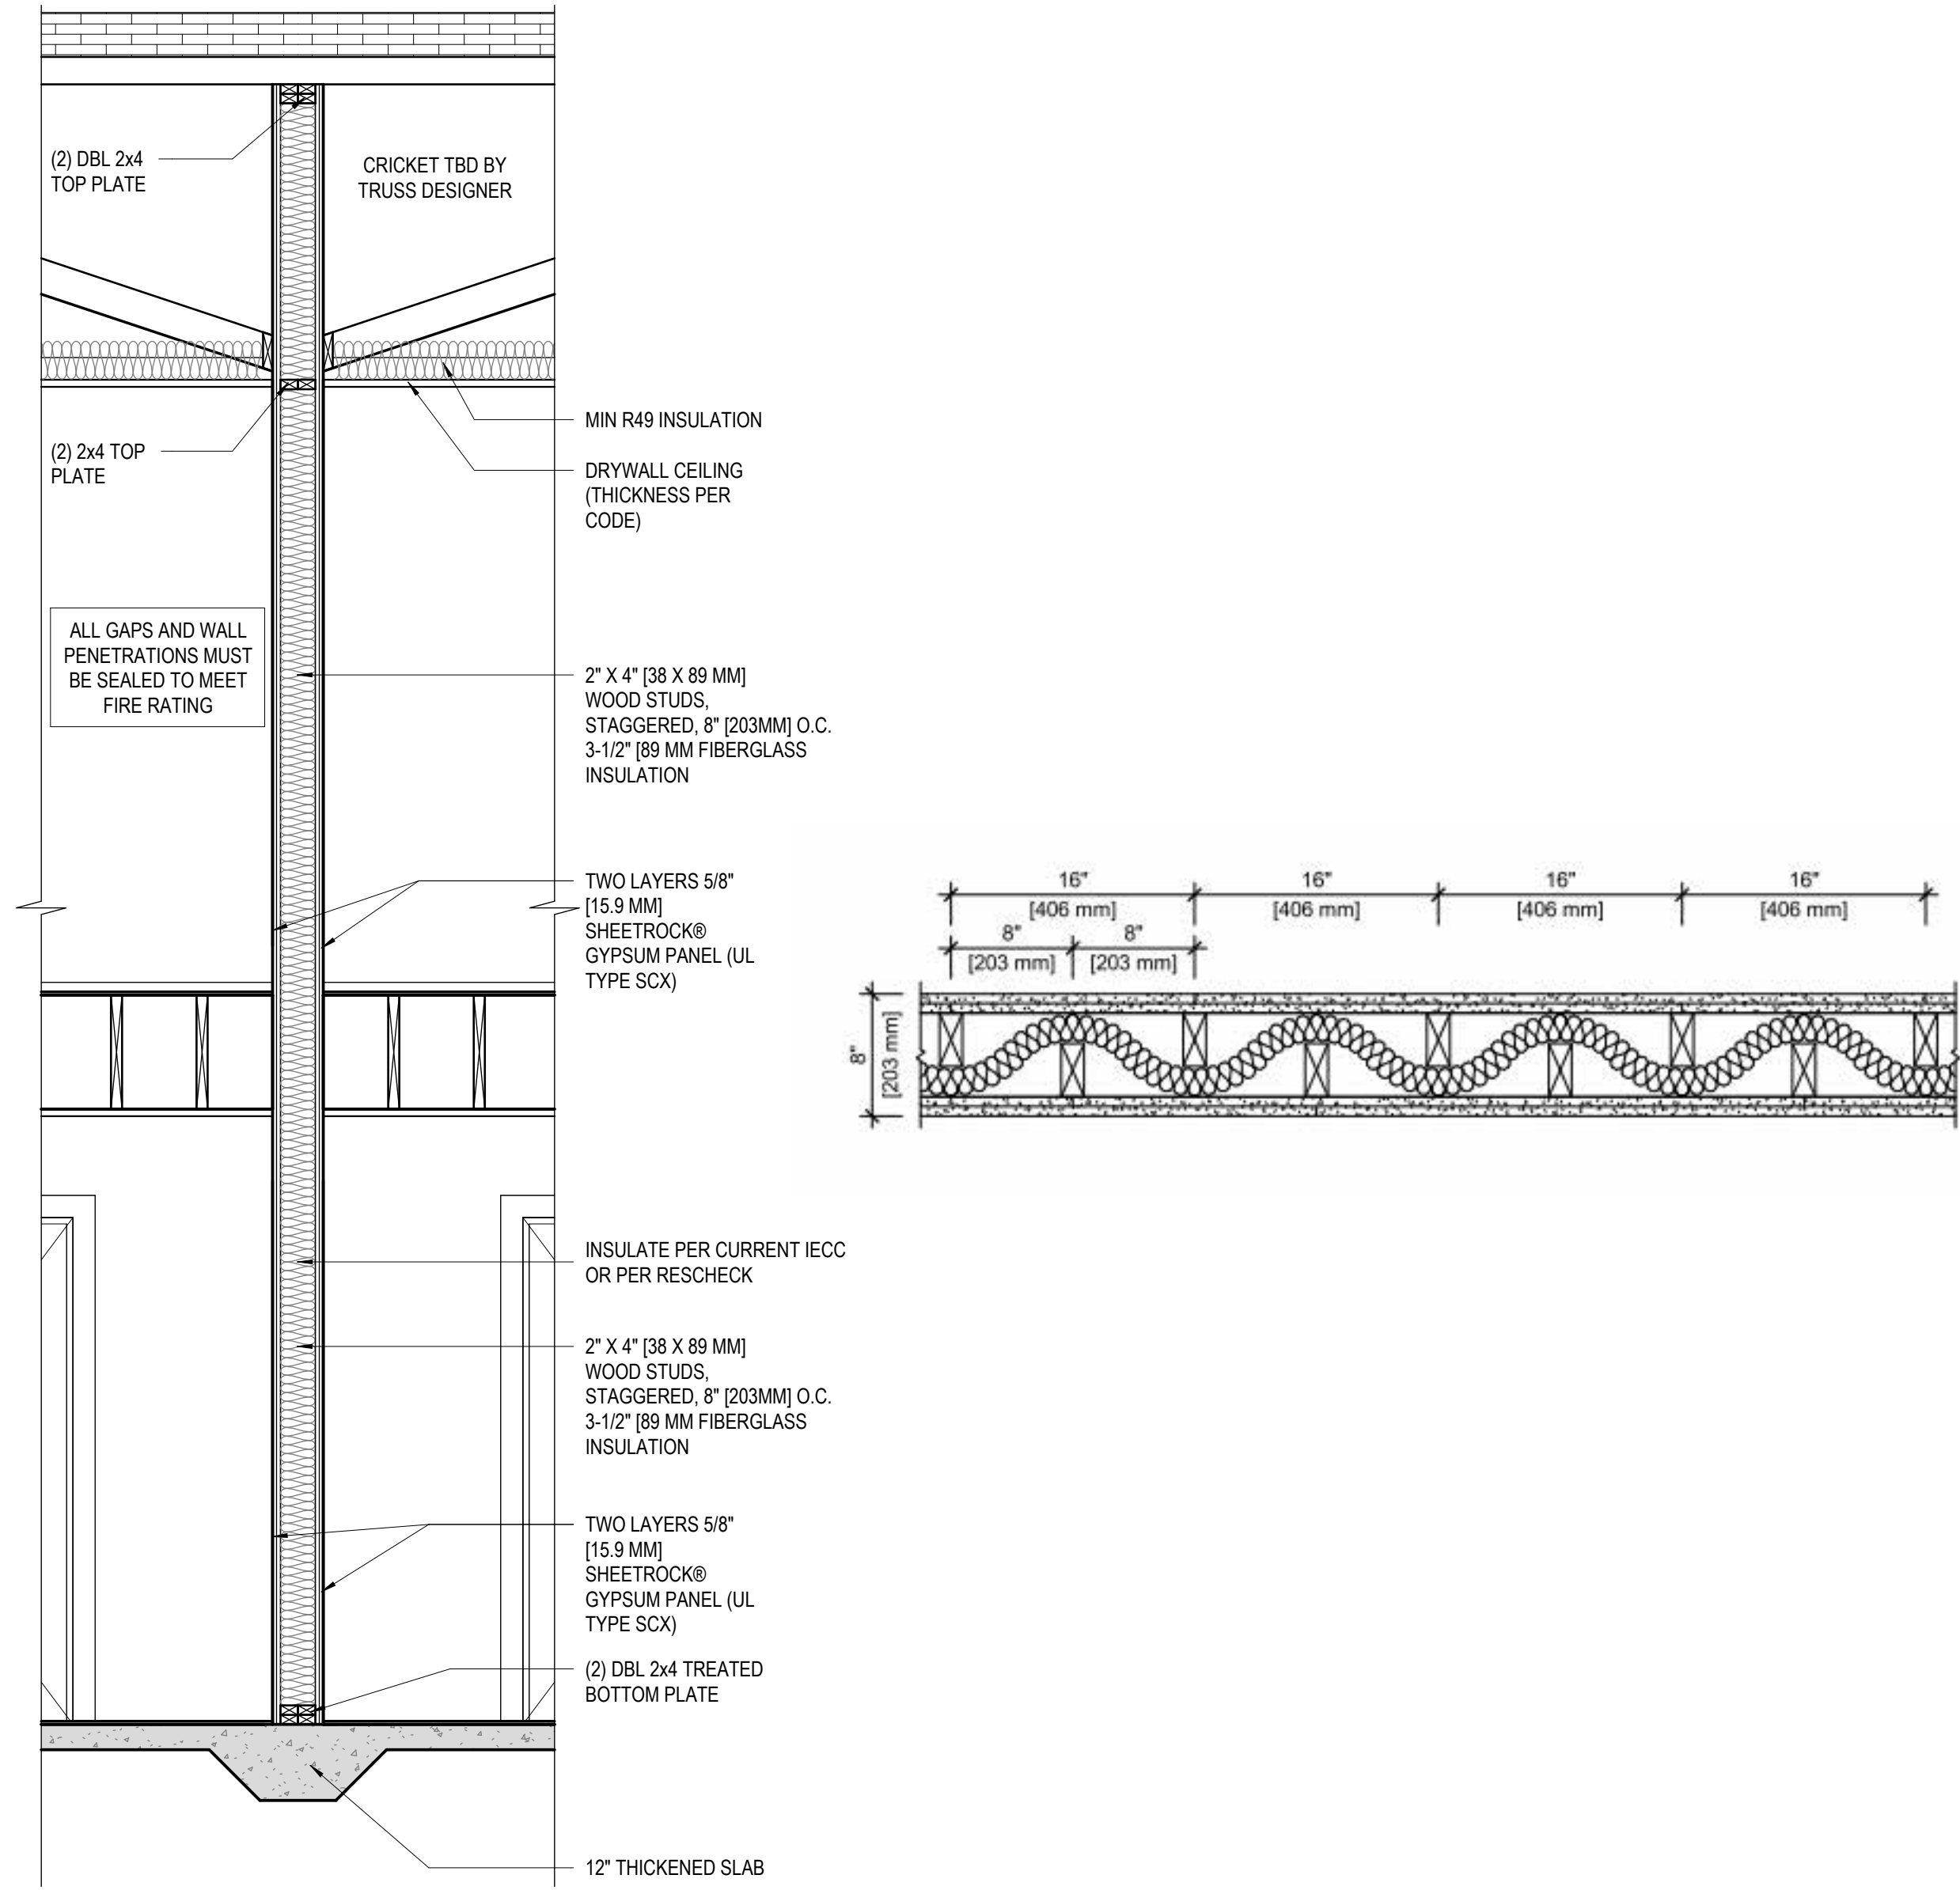

2 **FIREWALL BETWEEN 2 UNITS**
1/2" = 1'-0"

These drawings are the property of VirtuActive, LLC and are not to be reproduced, copied, or used in any way without the written permission of VirtuActive, LLC. It is the responsibility of the contractor, sub-contractor, supplier, and/or homeowner to verify all dimensions and specifications shown on these drawings. The contractor, sub-contractor, supplier, and/or homeowner shall be responsible for all costs and liability for negligence on the job due to lack of knowledge or lack of plan detail from the sub-structural members, site suitability, and dimensions shall be verified by the contractor, sub-contractor, supplier, and/or owner.


PREPARED FOR:	PROJECT LOCATION:
	ADDRESS
HOMESTEAD COMMUNITIES DUPLEX Client Name	




VIRTUACTIVE

PRELIMINARY PLANS,
NOT FOR CONSTRUCTION

ELECTRICAL - DATA - AUDIO LEGEND	
SYMBOL	DESCRIPTION
	110V Receptacles: Duplex
	110V Receptacles: GFCI
	110V Single Receptacle: Microwave
	110V Single Receptacle: Refrigerator
	110V Receptacles: WP
	220V/240V Receptacles: Clothes Dryer
	220V/240V Receptacles: Oven
	Ceiling Fan w/ Light
	CO-Smoke Detector: Ceiling Mounted
	Special Purpose Duplex Receptacle: Dishwasher
	Ceiling Mounted Light Fixture: Fixture
	Ceiling Mounted Light Fixture: Keyless
	Ceiling Mounted Light Fixture: Wafers w/ weatherproof
	Ceiling Mounted Light Fixture: Recessed
	110V Single Receptacles: Garbage Disposal
	Special Purpose Single Receptacle: Washing Machine
	Switch: 3-Way
	Switch: Single Pole
	Smoke Detector: Ceiling Mounted
	Receptacles: TV
	Ventilation Fans: Ceiling Mounted
	Wall Mounted Light Fixture: Triple
CONTRACTOR, ELECTRICIAN, & HOMEOWNER TO SITE VERIFY FIXTURE TYPE, LOCATION, QUANTITY, & CODE COMPLIANCE	

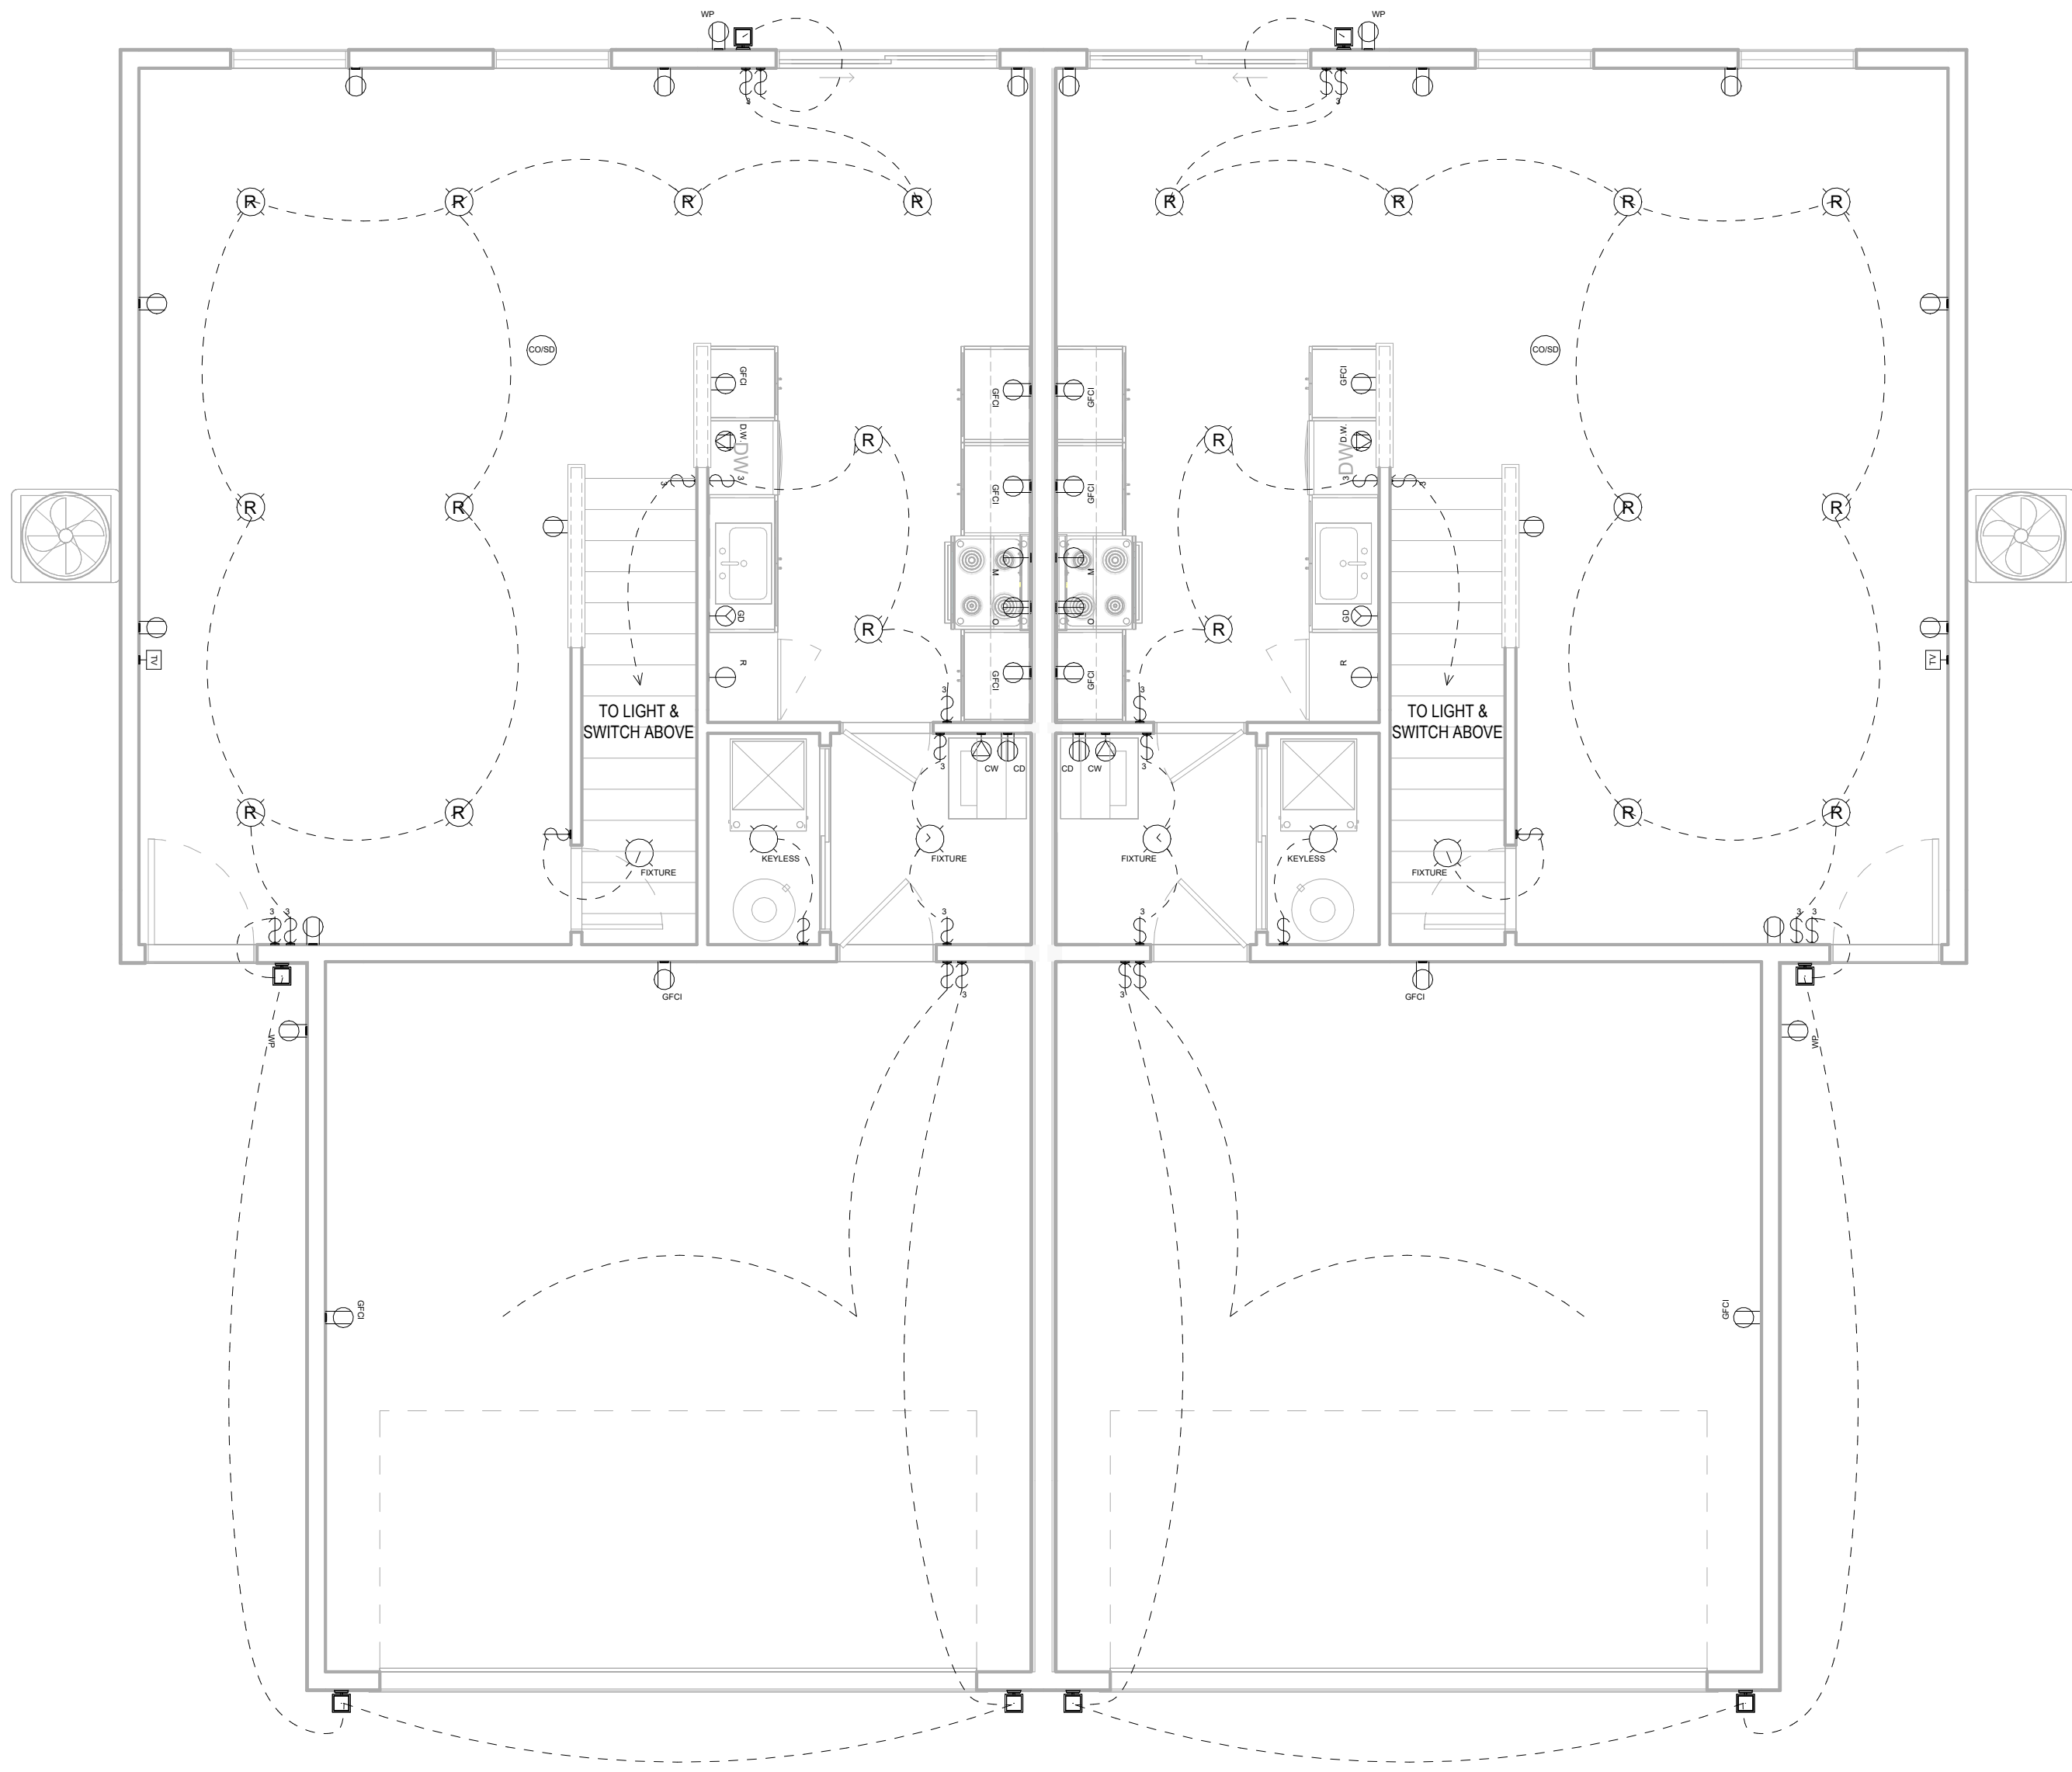

1
**TRANSITIONAL
1ST FLOOR ELECTRICAL PLAN**
1/4" = 1'-0"

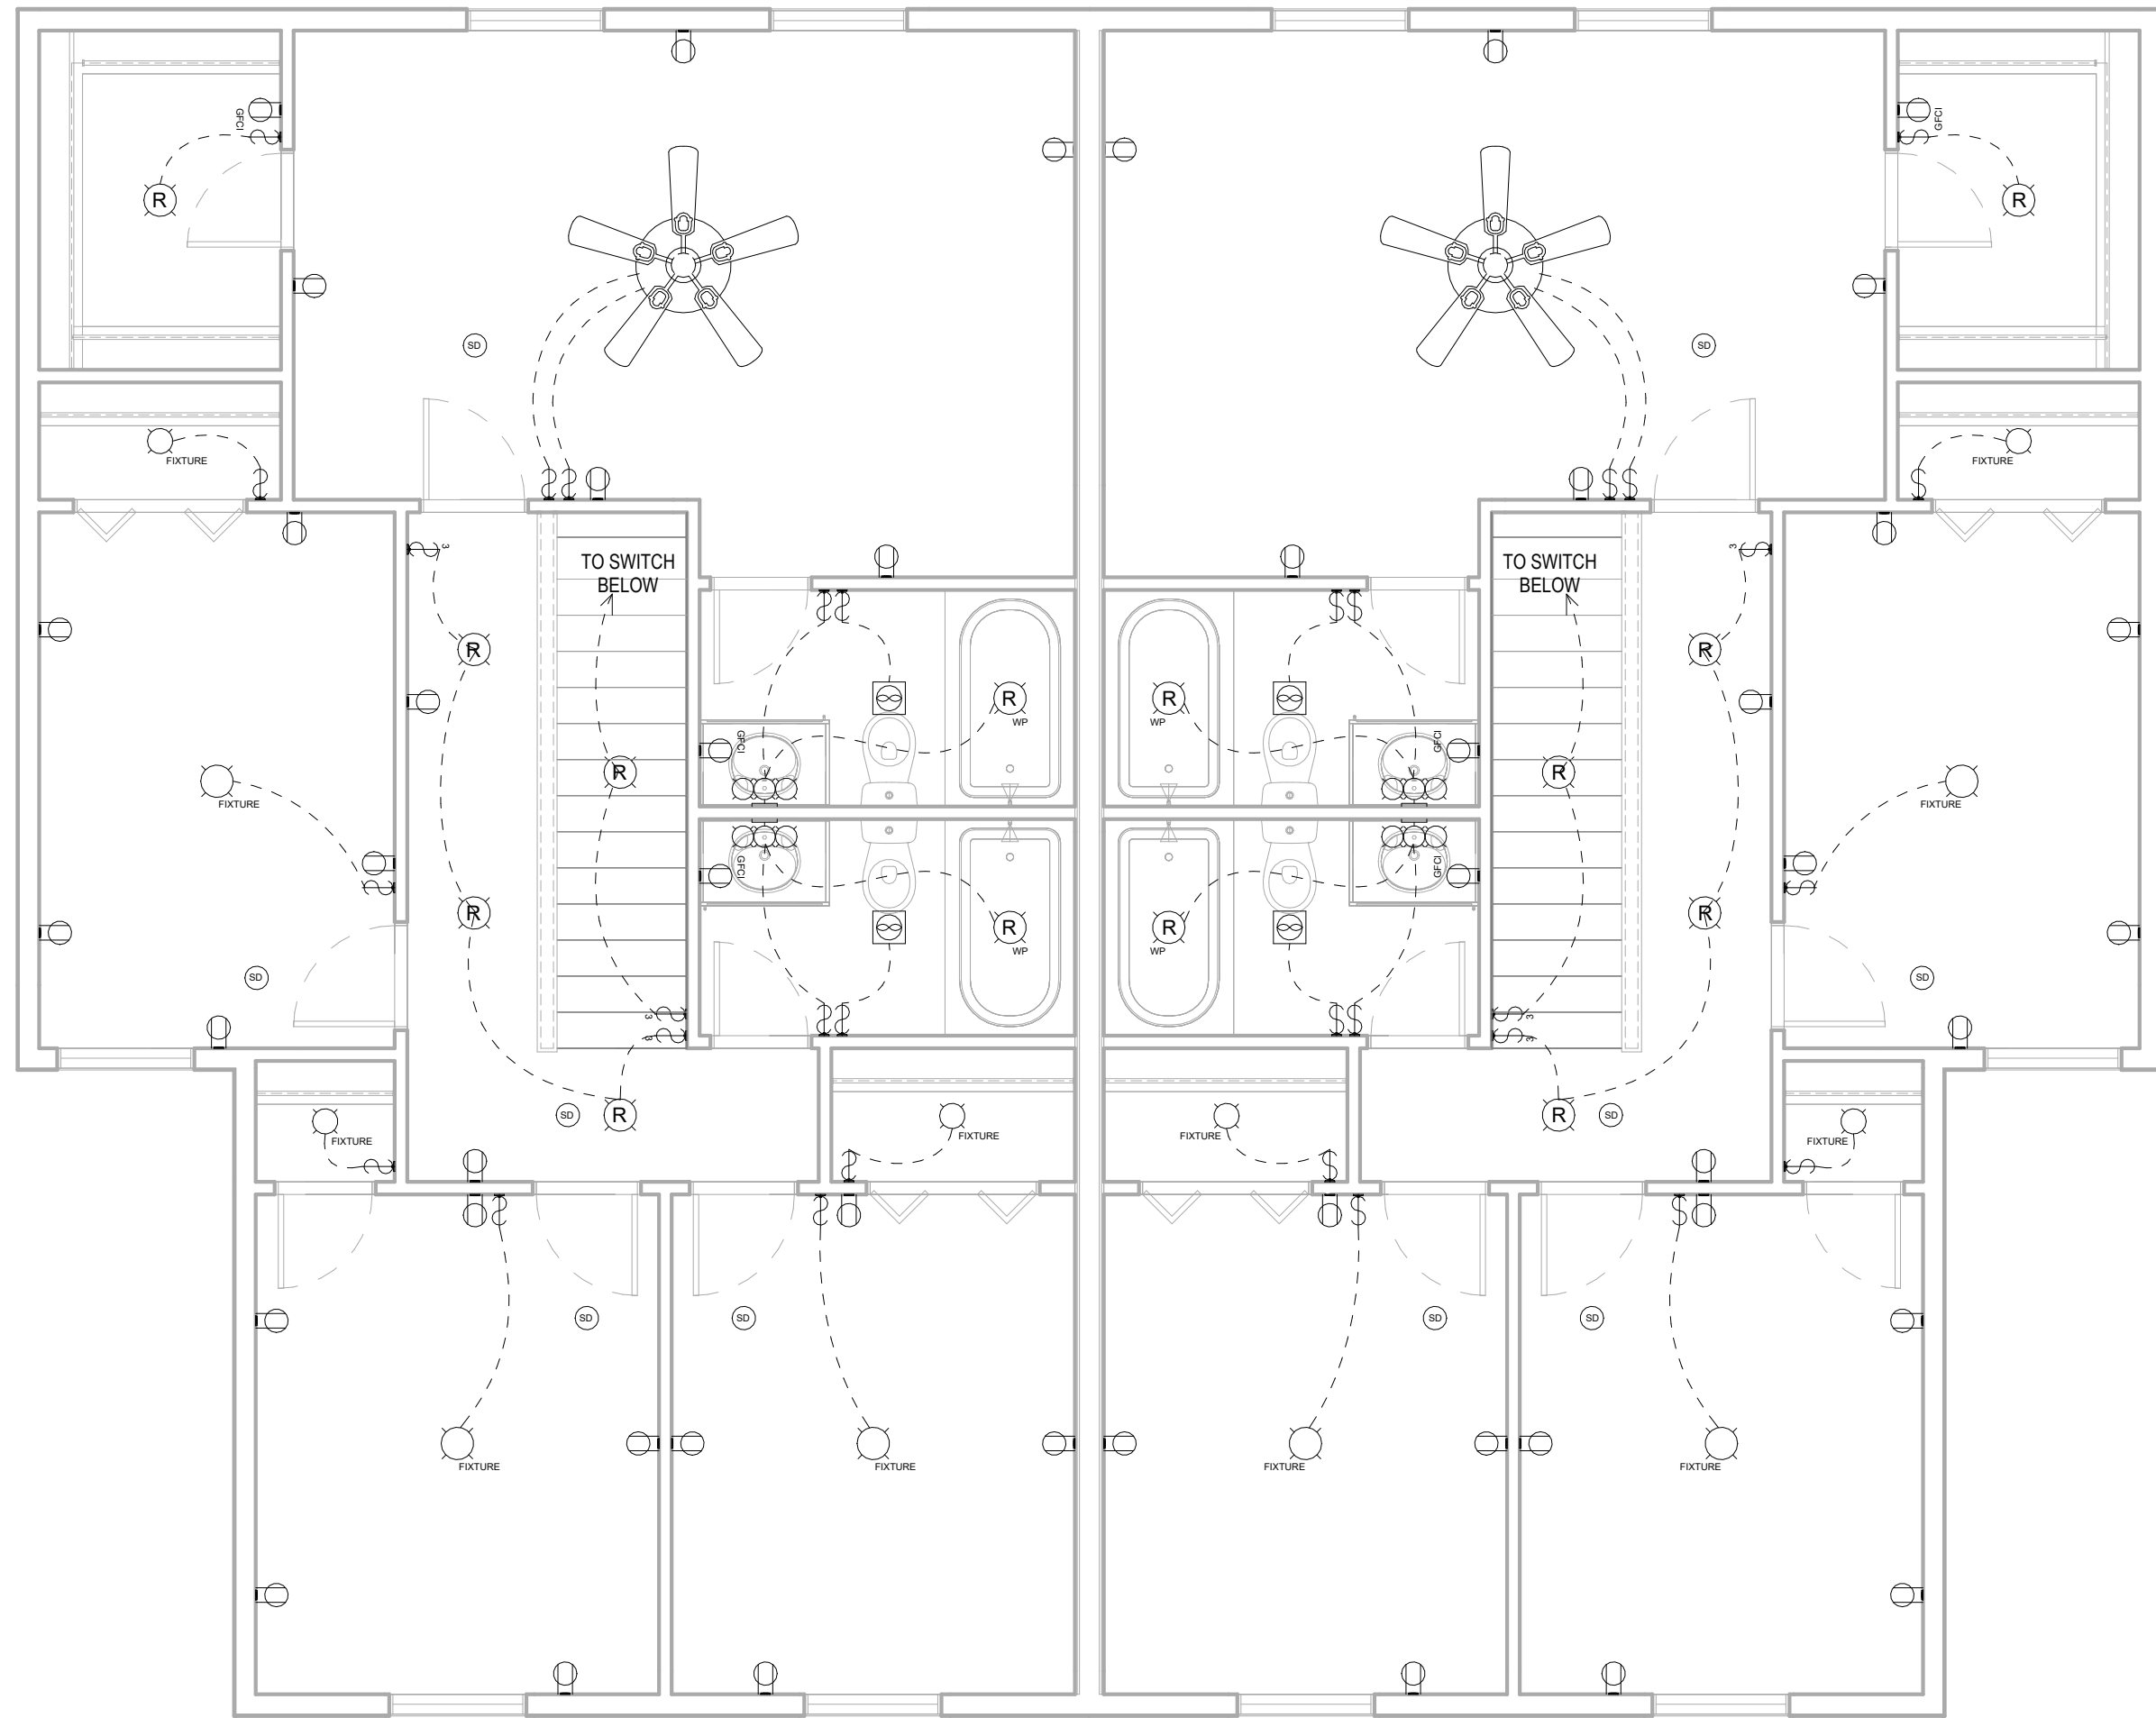

2
**TRANSITIONAL
2ND FLOOR ELECTRICAL PLAN**
1/4" = 1'-0"



REVISION TABLE	NUMBER	DATE	REVISED BY	DESCRIPTION

These drawings are the property of VirtuActive, LLC and are not to be reproduced or used in any way without the written permission of VirtuActive, LLC. Use of these drawings and concepts contained herein without the written permission of VirtuActive, LLC is prohibited. The contractor, sub-contractor, supplier, and/or homeowner shall verify all dimensions and quantities shown on these drawings. The contractor, sub-contractor, supplier, and/or homeowner must check all dimensions and other details prior to construction and be solely responsible for any discrepancies. VirtuActive, LLC is not responsible for any discrepancies or errors. The contractor, sub-contractor, supplier, and/or homeowner shall be responsible for all code and safety requirements. The contractor, sub-contractor, supplier, and/or homeowner shall be responsible for all structural members, site suitability, and dimensions shall be verified by the contractor, sub-contractor, supplier, and/or owner.

PREPARED FOR:	PROJECT LOCATION:
	ADDRESS
HOMESTEAD COMMUNITIES DUPLEX Client Name	


VIRTUACTIVE
VirtuActive - 3D Drafting & Design
1414 North 20th Street, Suite 2, Elkhorn, NE 68022
www.VirtuActive.com | 402.979.8100

DATE:
10/7/2025
SHEET:
PAGE 10




VIRTUACTIVE

PRELIMINARY PLANS,
NOT FOR CONSTRUCTION

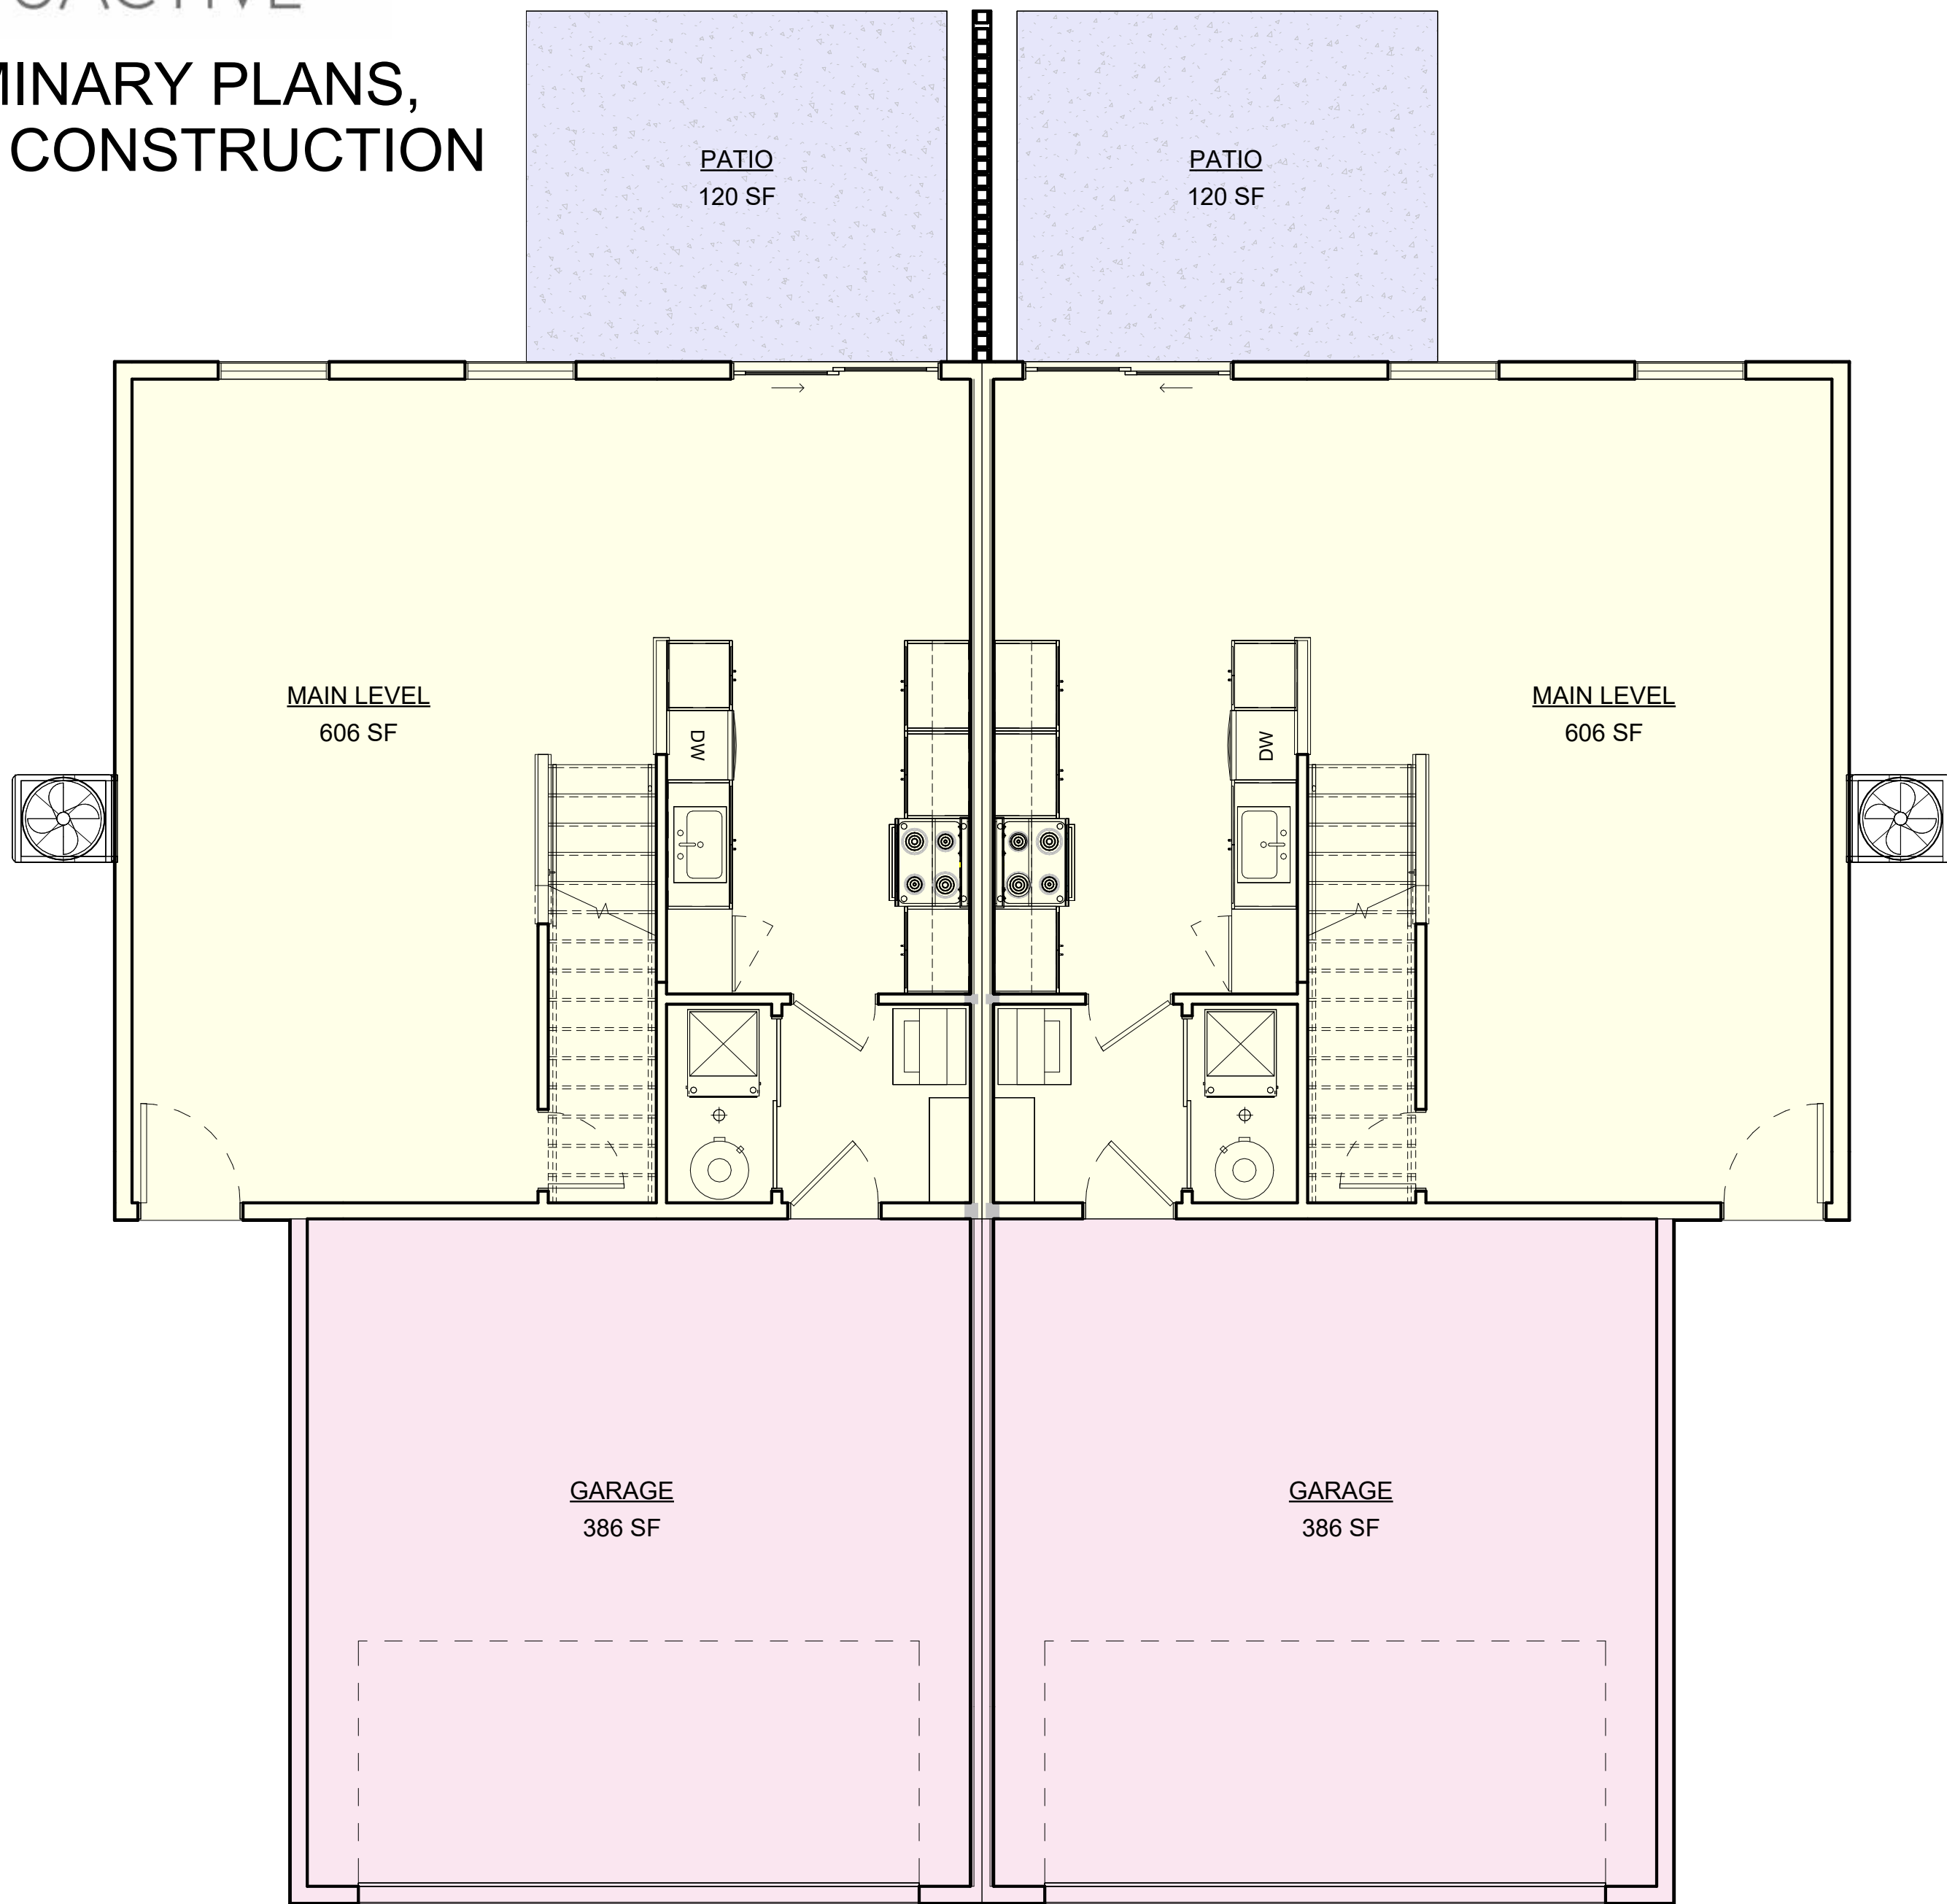

1 **TRANSITIONAL
MAIN LEVEL AREA PLAN**
1/4" = 1'-0"

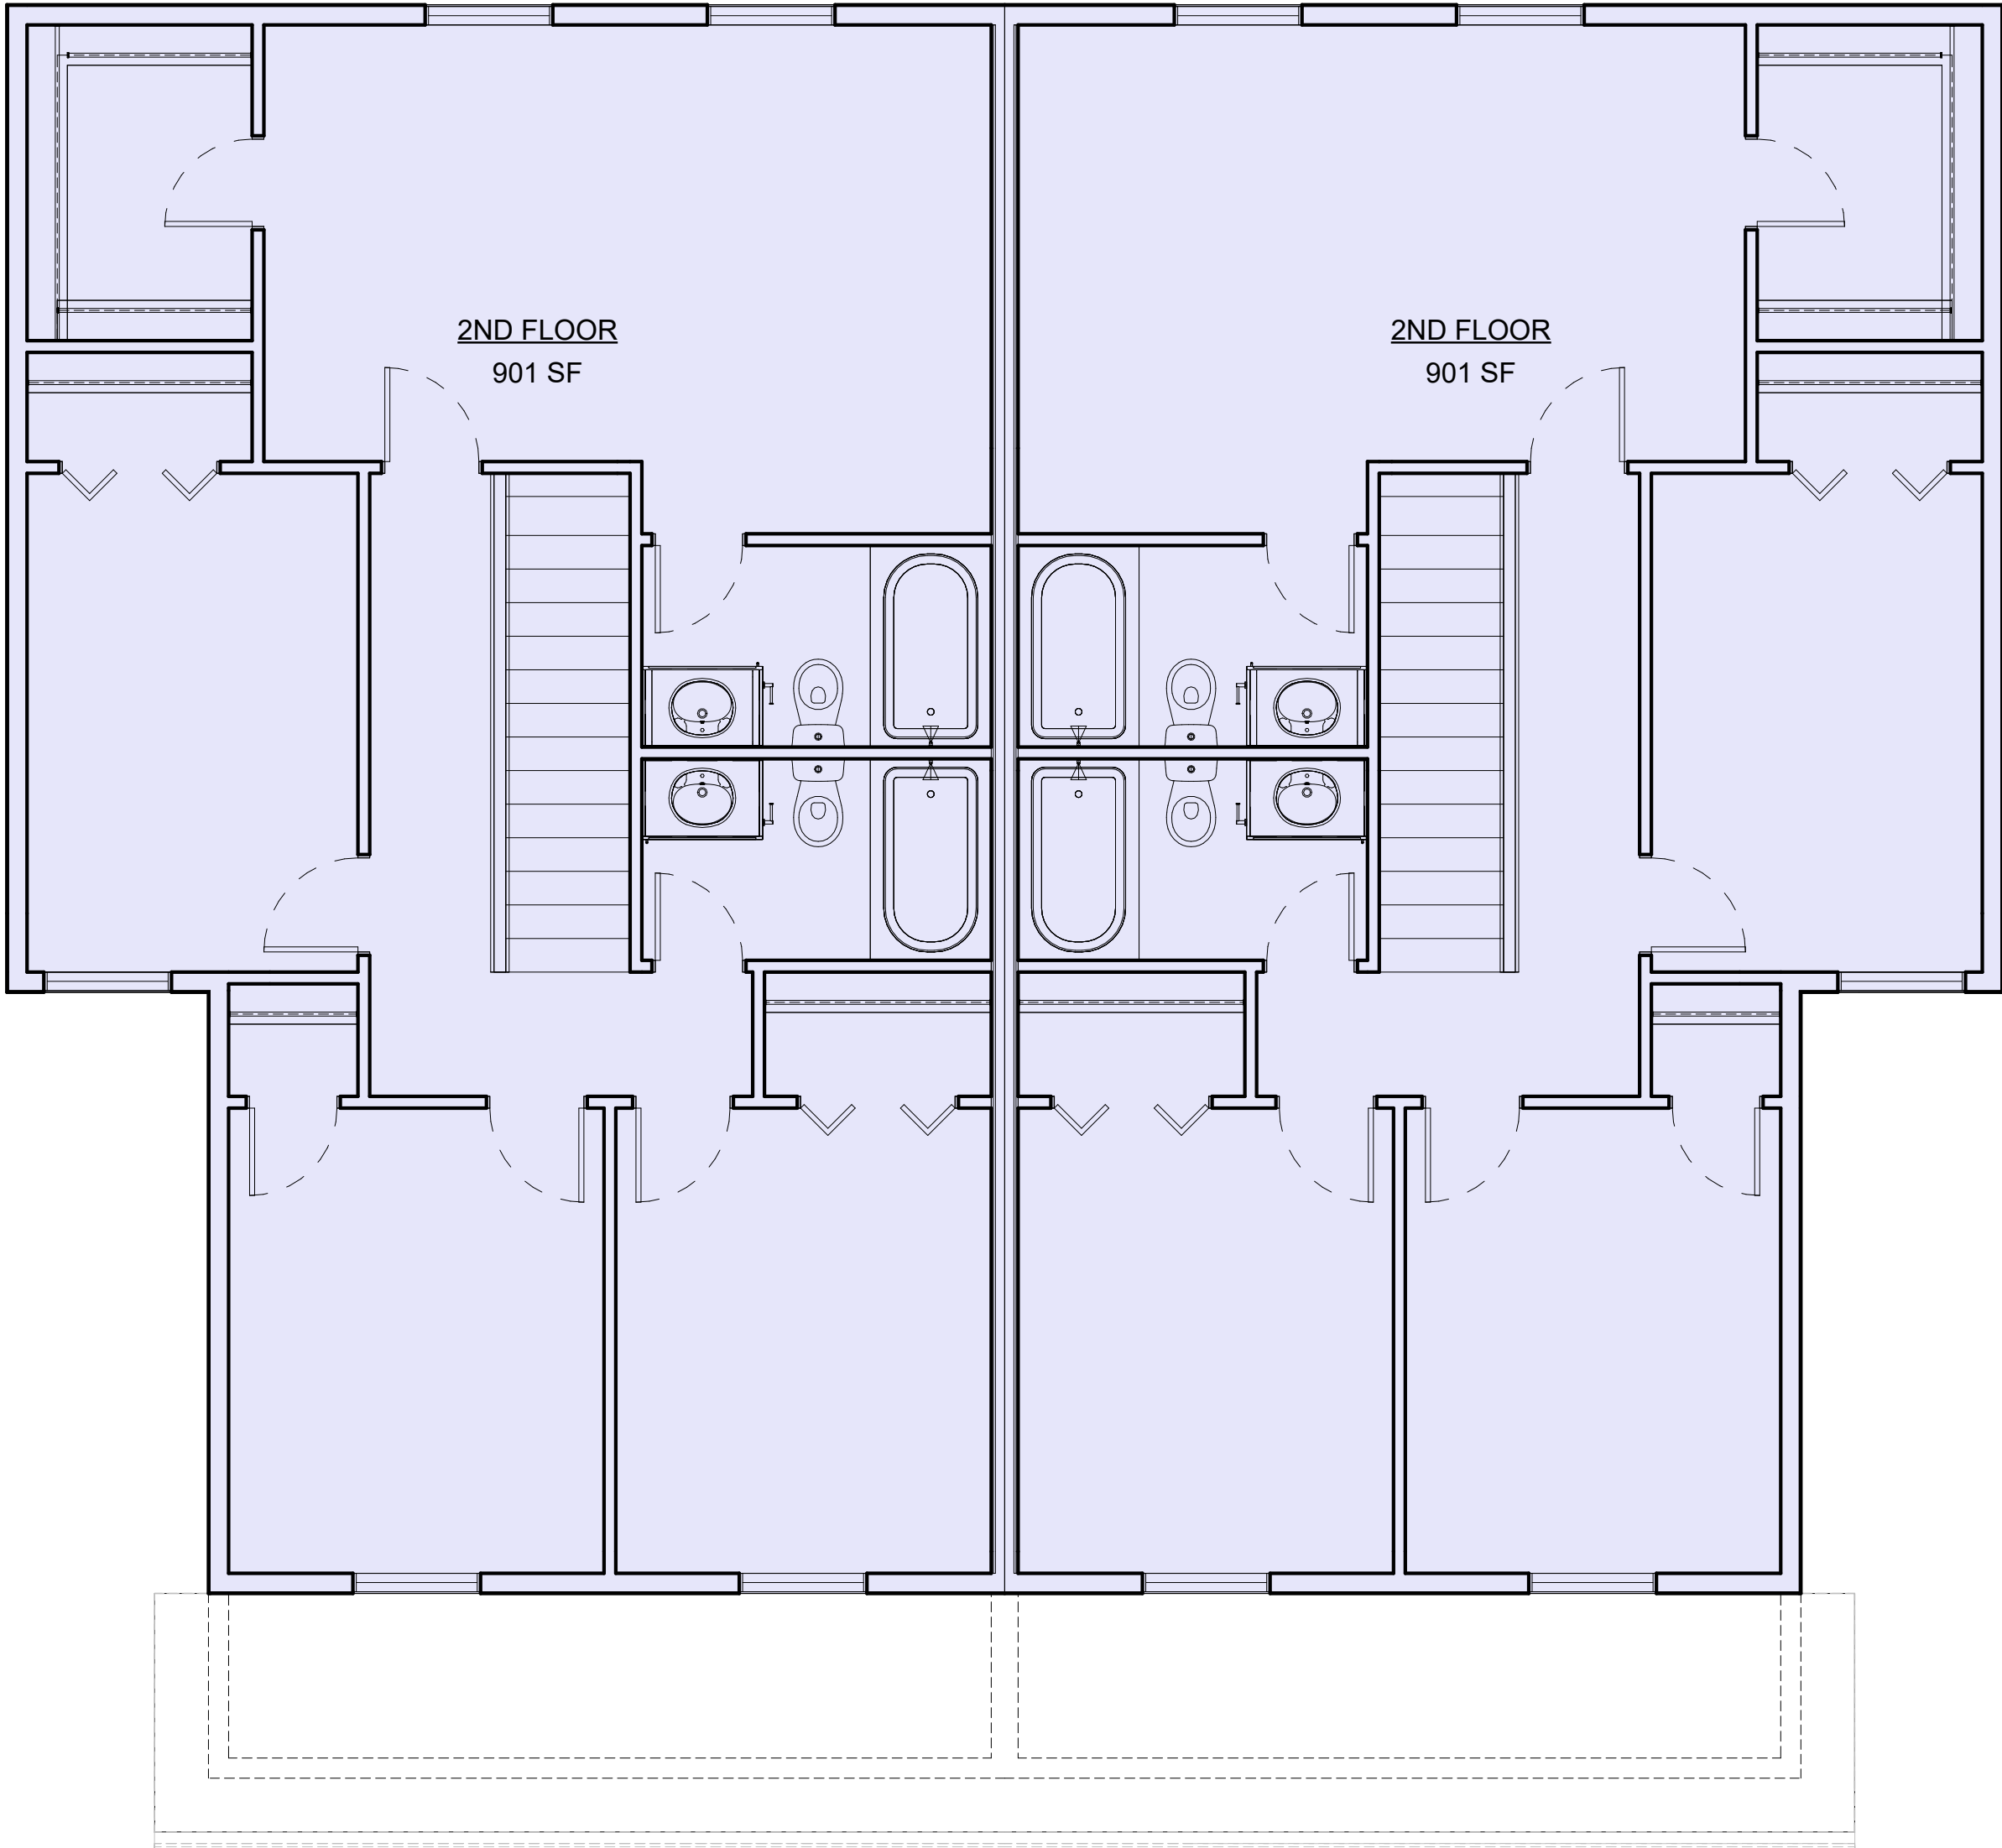

2 **TRANSITIONAL
UPPER LEVEL AREA PLAN**
1/4" = 1'-0"

These drawings are the property of VirtuActive, LLC and are not to be reproduced, copied, or used in any way without the written permission of VirtuActive, LLC. Use of these drawings and concepts contained herein without the written permission of VirtuActive, LLC is prohibited. The contractor, sub-contractors, suppliers, and/or homeowners shall verify all dimensions and must check all dimensions and other details prior to construction and be solely responsible for any discrepancies. VirtuActive, LLC and its representatives are not responsible for any errors or omissions on the drawings due to lack of knowledge or lack of data detail from the sub-structural members, site suitability, and dimensions shall be verified by the contractor, sub-contractors, suppliers, and/or owner.

PREPARED FOR:	PROJECT LOCATION:
	ADDRESS
HOMESTEAD COMMUNITIES	
DUPLEX	
Client Name	

VIRTUACTIVE
VirtuActive - 3D Drafting & Design
1414 North 20th Street, Suite 2, Elkhorn, NE 68022
www.VirtuActive.com | 402.979.8100

DATE:
10/7/2025
SHEET:
PAGE 11

NUMBER	DATE	REVISION TABLE BY	DESCRIPTION